

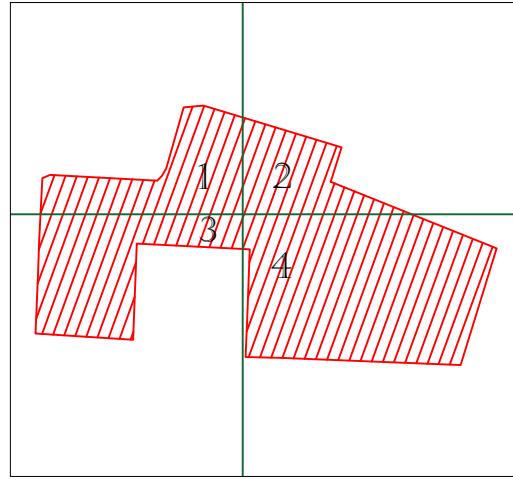


# MASTER PLAN OF THQ HOSPITAL AHMAD PUR SIAL

PART 1

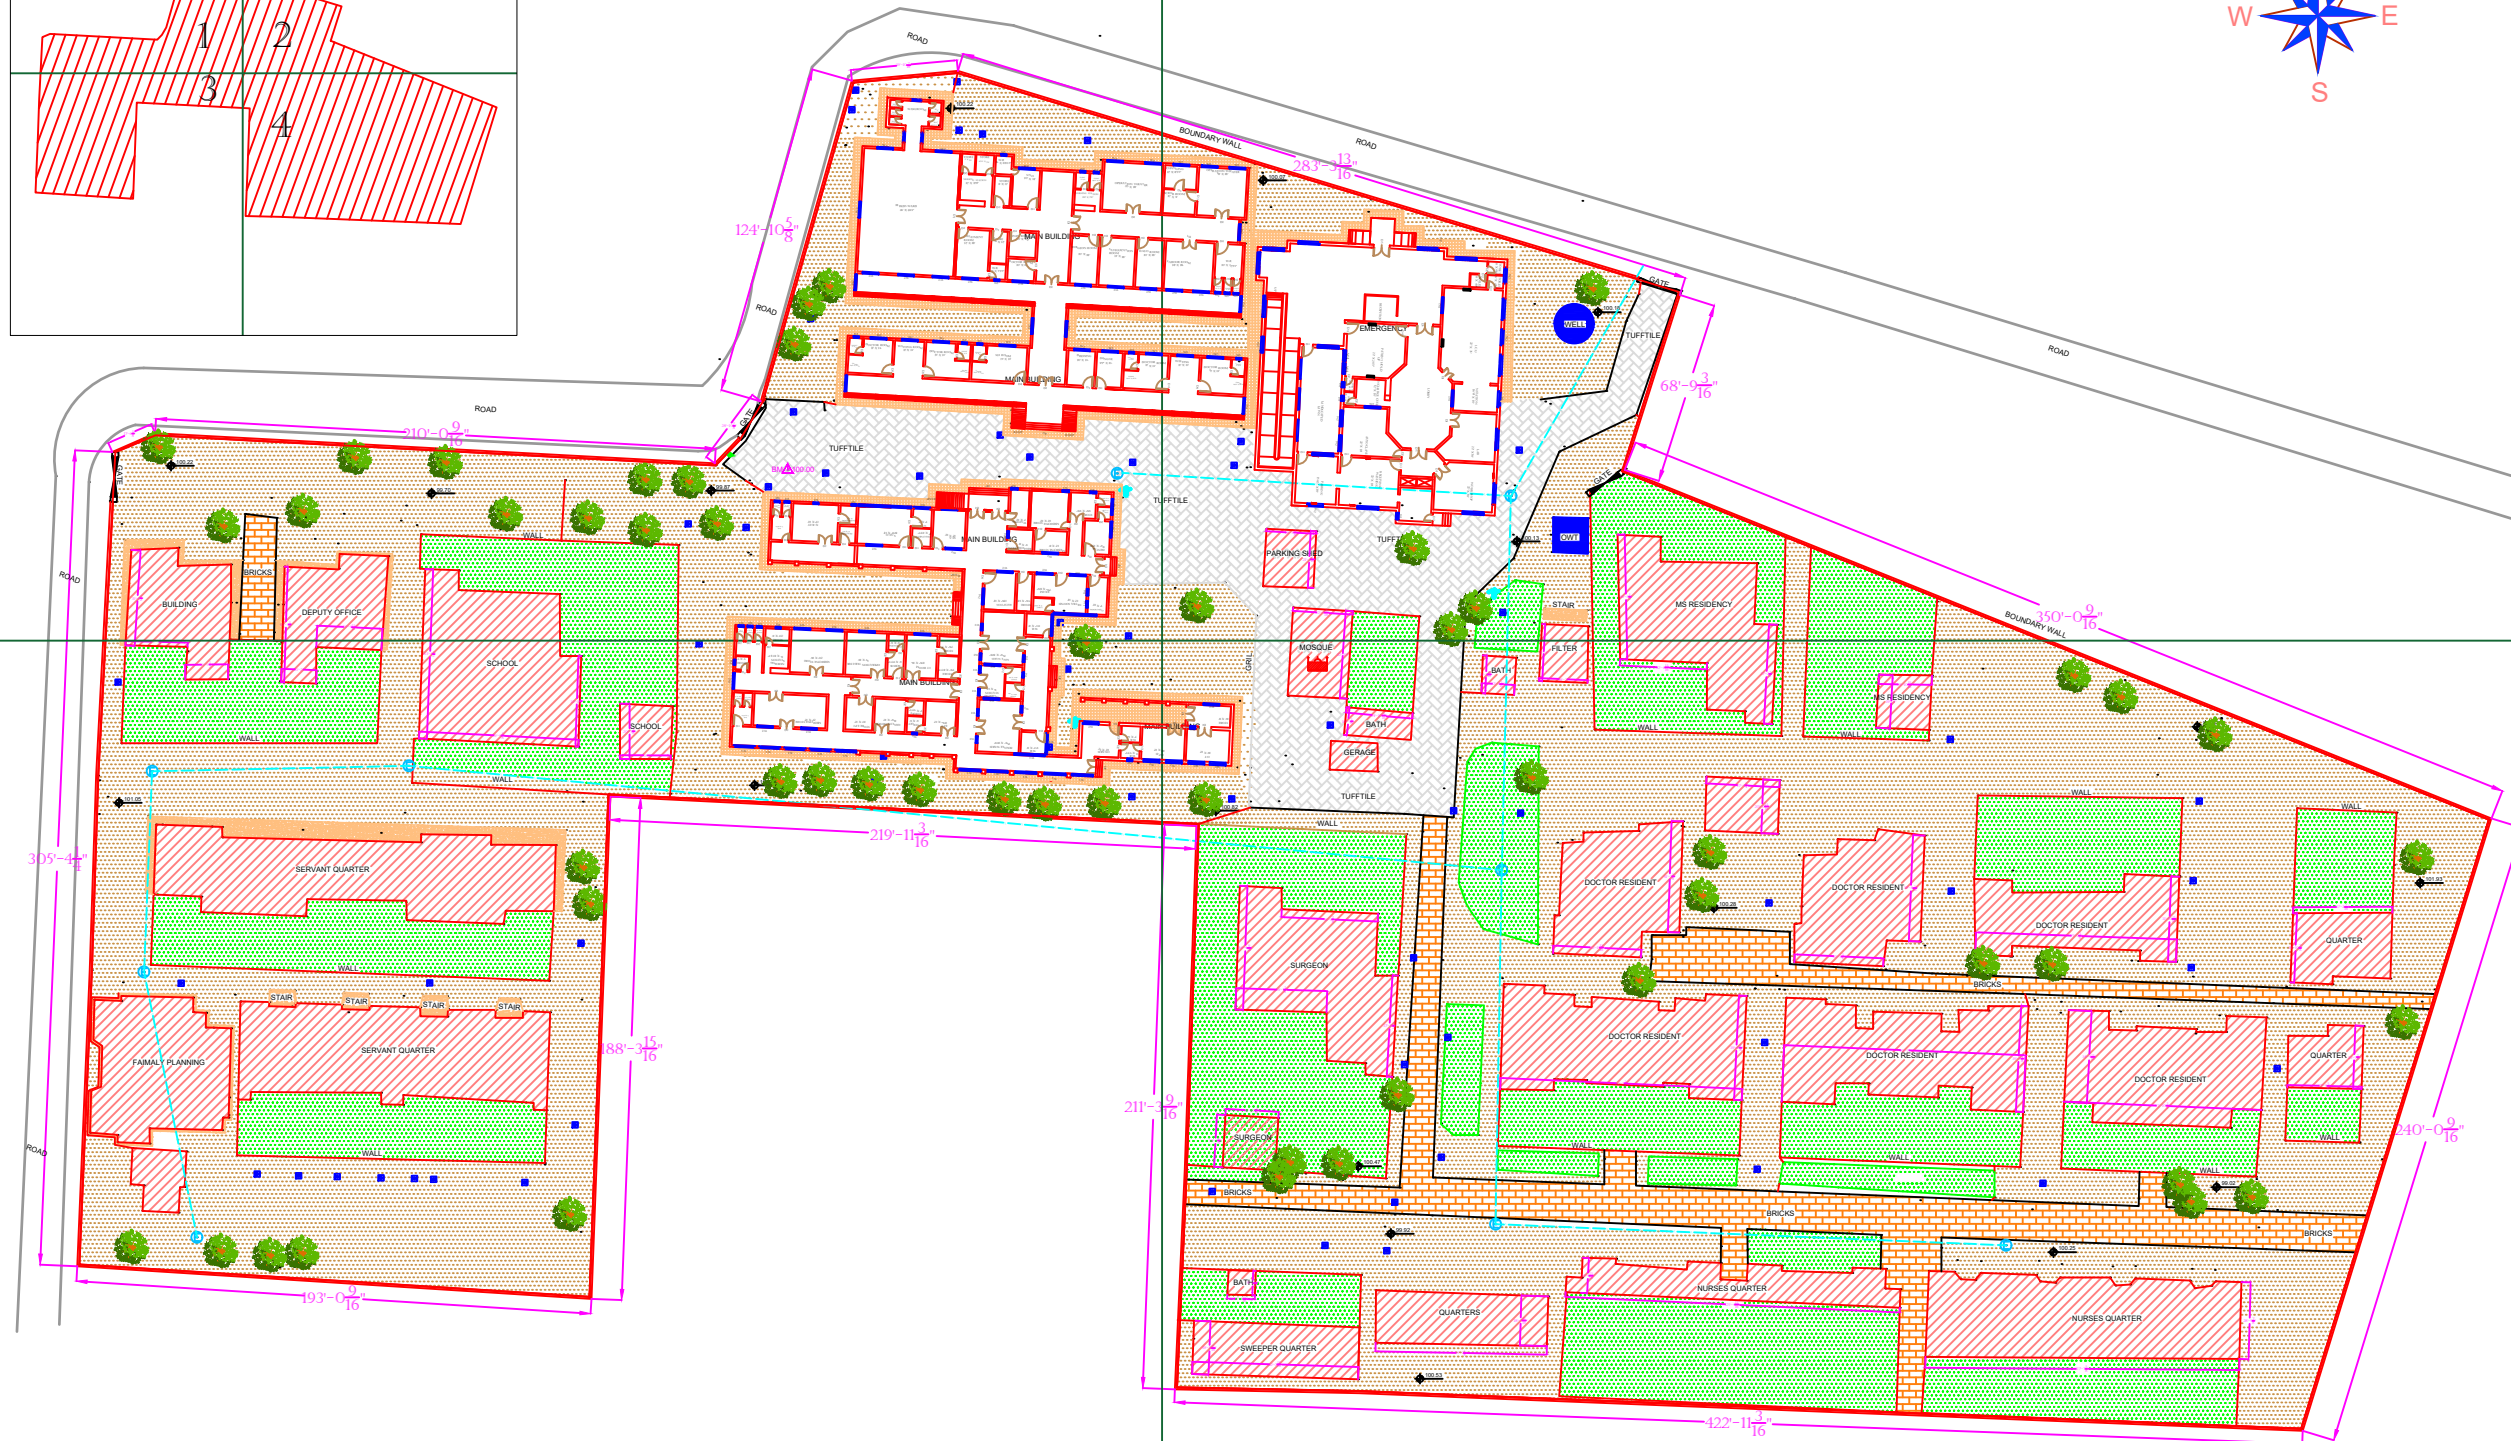

PART 2

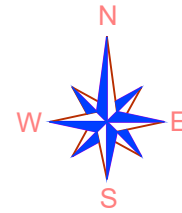

**Legends:**

Residential Area	
Road	
Wall	
Power Line	
OHT	
Tree	
Man Hole	
Tube Well	
Light Pole	
Lawns	
Earthen Areas	
Asphalts Roads	
Tough Pavers	
P.C.C / Plinth Protection	
Boundary Wall	
Brick Pavers / Soling	
Drain	
Tap	
Hand Pump	
Air Conditioner	
Tube Light	
Fan	
Roof Light	
Bulb	

**AREA**

AREA WITHIN BOUNDARY WALL	26650.859 SFT
AREA OF CLINICAL BLOCK	41470.792 SFT
PLINTH AREA OF BLOCK	32705.683 SFT

**OPENING SCHEDULE OF DOORS AND WINDOWS**

DOORS	WIDTH	HEIGHT	WINDOWS	WIDTH	HEIGHT
D1	5'-0"	7'-0"	W1	3'-0"	3'-0"
D2	2'-6"	7'-0"	W2	6'-0"	6'-0"
D3	3'-6"	7'-0"	W3	8'-0"	8'-0"
D4	4'-0"	7'-0"			
D5	6'-0"	7'-0"			
D6	2'-0"	7'-0"			
D7	3'-0"	7'-0"			

Project:  
**CAD MAPPING OF TEHSIL HEAD QUARTER HOSPITALS, PUNJAB**

Client: GOVERNMENT OF THE PUNJAB  
PRIMARY & SECONDARY HEALTHCARE DEPARTMENT

Consultant: SKAFS CONSULTANT (Pvt.) Limited  
ENGINEERING AND ENVIRONMENT CONSULTANT

Drawing Title:  
**THQ AHMAD PUR SIAL HOSPITAL MASTER PLAN**


Drawing No. **SKAFS/A-P-SIAL /03**

PART 3

PART 4

# MASTER PLAN OF THQ HOSPITAL AHMAD PUR SIAL

## PART 1

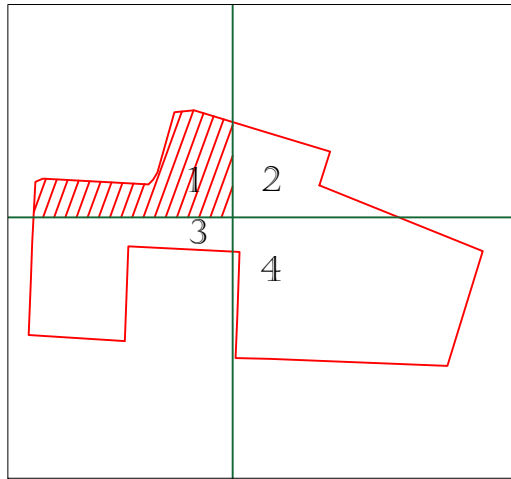

### Legends:

Residential Area	
Road	
Wall	
Power Line	
OHT	
Tree	
Man Hole	
Tube Well	
Light Pole	
Lawns	
Earthen Areas	
Asphalts Roads	
Tough Pavers	
P.C.C / Plinth Protection	
Boundary Wall	
Brick Pavers / Soling	
Drain	
Tap	
Hand Pump	
Air Conditioner	
Tube Light	
Fan	
Roof Light	
Bulb	

AREA	
AREA WITHIN BOUNDARY WALL	266550.859 SFT
AREA OF CLINICAL BLOCK	41470.792 SFT
PLINTH AREA OF BLOCK	32705.683 SFT

### OPENING SCHEDULE OF DOORS AND WINDOWS

DOORS	WIDTH	HEIGHT	WINDOWS	WIDTH	HEIGHT
D1	5'-0"	7'-0"	W1	3'-0"	3'-0"
D2	2'-6"	7'-0"	W2	6'-0"	6'-0"
D3	3'-6"	7'-0"	W3	8'-0"	8'-0"
D4	4'-0"	7'-0"			
D5	6'-0"	7'-0"			
D6	2'-0"	7'-0"			
D7	3'-0"	7'-0"			

Project:  
**CAD MAPPING OF TEHSIL HEAD QUARTER HOSPITALS, PUNJAB**

Client: GOVERNMENT OF THE PUNJAB  
PRIMARY & SECONDARY HEALTHCARE DEPARTMENT

Consultant: SKAFS CONSULTANT (Pvt.) Limited  
ENGINEERING AND ENVIRONMENT CONSULTANT




Drawing Title:  
**THQ AHMAD PUR SIAL HOSPITAL MASTER PLAN PART 1**

Drawing No. **SKAFS/A-P-SIAL /04**



# MASTER PLAN OF THQ HOSPITAL AHMAD PUR SIAL

## PART 2

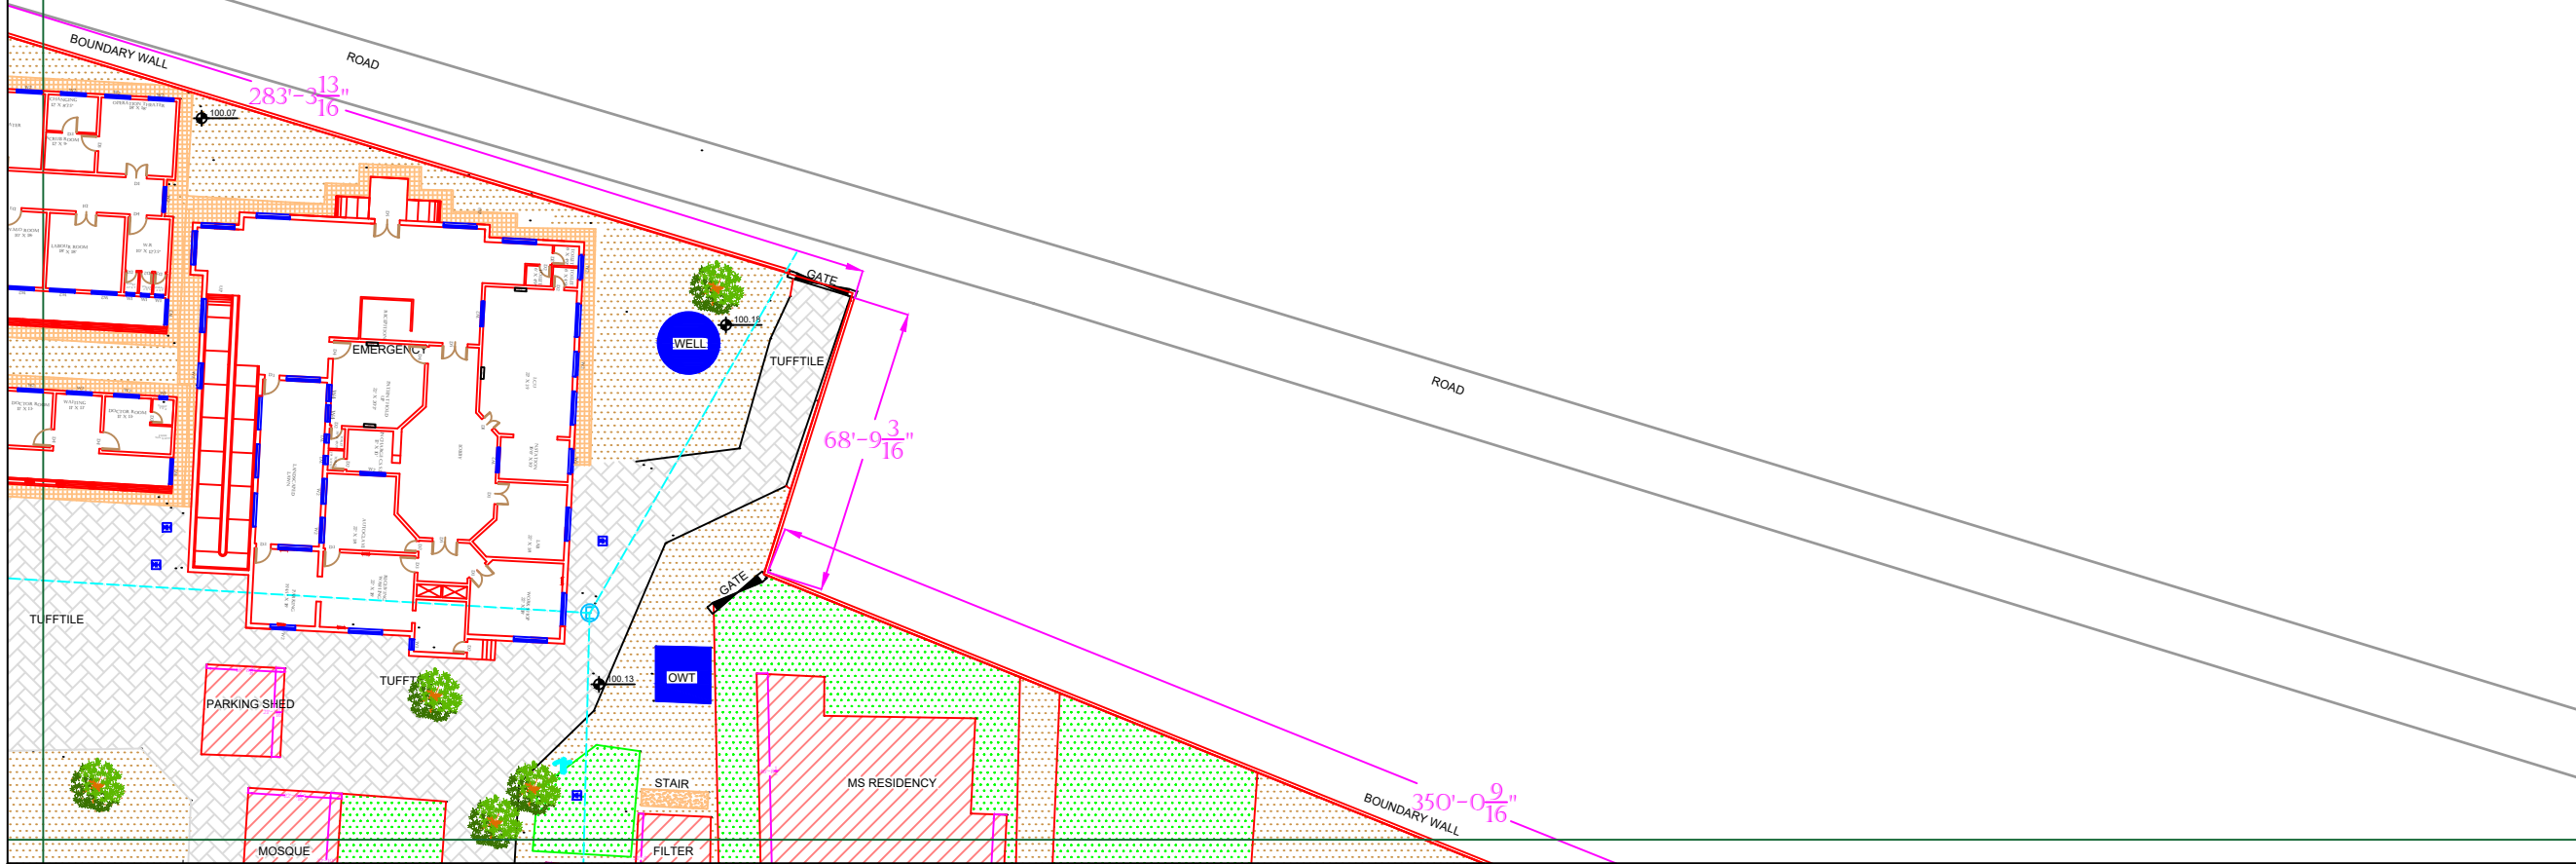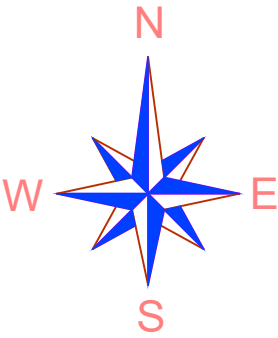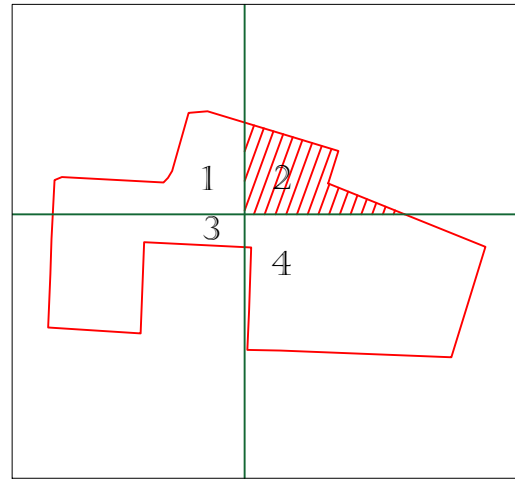

**Legends:**

Residential Area	
Road	
Wall	
Power Line	
OHT	
Tree	
Man Hole	
Tube Well	
Light Pole	
Lawns	
Earthen Areas	
Asphalts Roads	
Tough Pavers	
P.C.C / Plinth Protection	
Boundary Wall	
Brick Pavers / Soling	
Drain	
Tap	
Hand Pump	
Air Conditioner	
Tube Light	
Fan	
Roof Light	
Bulb	

AREA	
AREA WITHIN BOUNDARY WALL	266550.859 SFT
AREA OF CLINICAL BLOCK	41470.792 SFT
PLINTH AREA OF BLOCK	32705.683 SFT

OPENING SCHEDULE OF DOORS AND WINDOWS					
DOORS	WIDTH	HEIGHT	WINDOWS	WIDTH	HEIGHT
D1	5'-0"	7'-0"	W1	3'-0"	3'-0"
D2	2'-6"	7'-0"	W2	6'-0"	6'-0"
D3	3'-6"	7'-0"	W3	8'-0"	8'-0"
D4	4'-0"	7'-0"			
D5	6'-0"	7'-0"			
D6	2'-0"	7'-0"			
D7	3'-0"	7'-0"			



Project:  
**CAD MAPPING OF TEHSIL HEAD QUARTER HOSPITALS, PUNJAB**

Client:  GOVERNMENT OF THE PUNJAB PRIMARY & SECONDARY HEALTHCARE DEPARTMENT	Consultant:  SKAFS CONSULTANT (Pvt.) Limited ENGINEERING AND ENVIRONMENT CONSULTANT
---	--

Drawing Title:  
**THQ AHMAD PUR SIAL HOSPITAL MASTER PLAN PART 2**

# MASTER PLAN OF THQ HOSPITAL AHMAD PUR SIAL

## PART 3

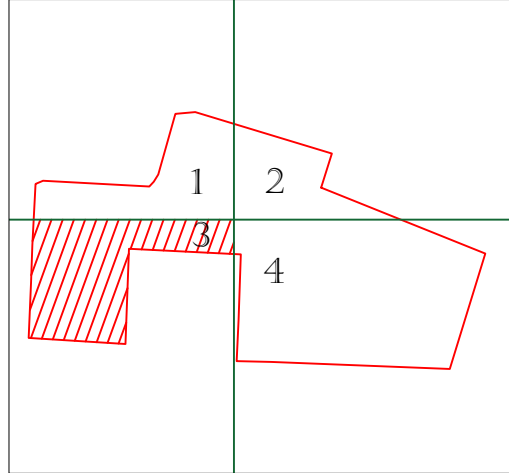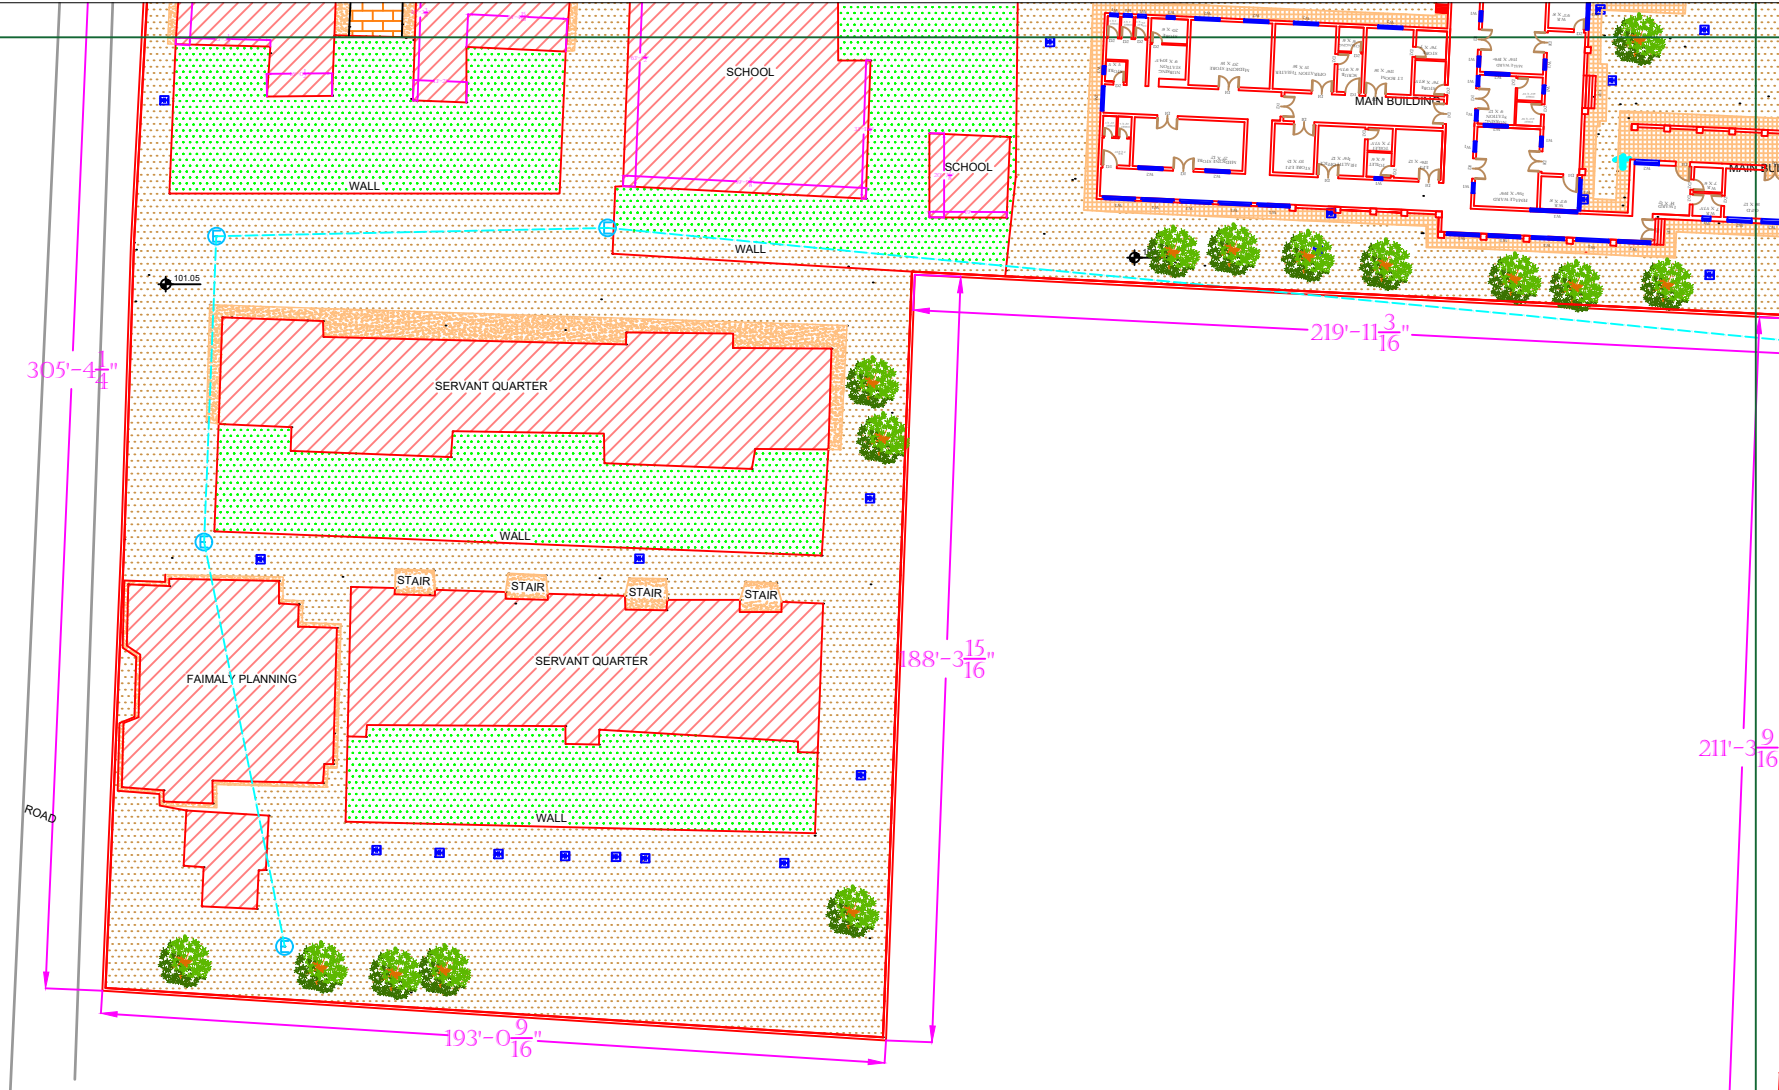

**Legends:**

Residential Area	
Road	
Wall	
Power Line	
OHT	
Tree	
Man Hole	
Tube Well	
Light Pole	
Lawns	
Earthen Areas	
Asphalts Roads	
Tough Pavers	
P.C.C / Plinth Protection	
Boundary Wall	
Brick Pavers / Soling	
Drain	
Tap	
Hand Pump	H.P.
Air Conditioner	AC
Tube Light	
Fan	
Roof Light	
Bulb	

AREA	
AREA WITHIN BOUNDARY WALL	266550.859 SFT
AREA OF CLINICAL BLOCK	41470.792 SFT
PLINTH AREA OF BLOCK	32705.683 SFT

OPENING SCHEDULE OF DOORS AND WINDOWS					
DOORS	WIDTH	HEIGHT	WINDOWS	WIDTH	HEIGHT
D1	5'-0"	7'-0"	W1	3'-0"	3'-0"
D2	2'-6"	7'-0"	W2	6'-0"	6'-0"
D3	3'-6"	7'-0"	W3	8'-0"	8'-0"
D4	4'-0"	7'-0"			
D5	6'-0"	7'-0"			
D6	2'-0"	7'-0"			
D7	3'-0"	7'-0"			

Project:  
**CAD MAPPING OF TEHSIL HEAD QUARTER HOSPITALS, PUNJAB**


Client:  GOVERNMENT OF THE PUNJAB PRIMARY & SECONDARY HEALTHCARE DEPARTMENT	Consultant:  SKAFS CONSULTANT (Pvt.) Limited ENGINEERING AND ENVIRONMENT CONSULTANT
---	--

Drawing Title:  
**THQ AHMAD PUR SIAL HOSPITAL MASTER PLAN PART 3**

Drawing No. **SKAFS/A-P-SIAL /06**

# MASTER PLAN OF THQ HOSPITAL AHMAD PUR SIAL

## PART 4

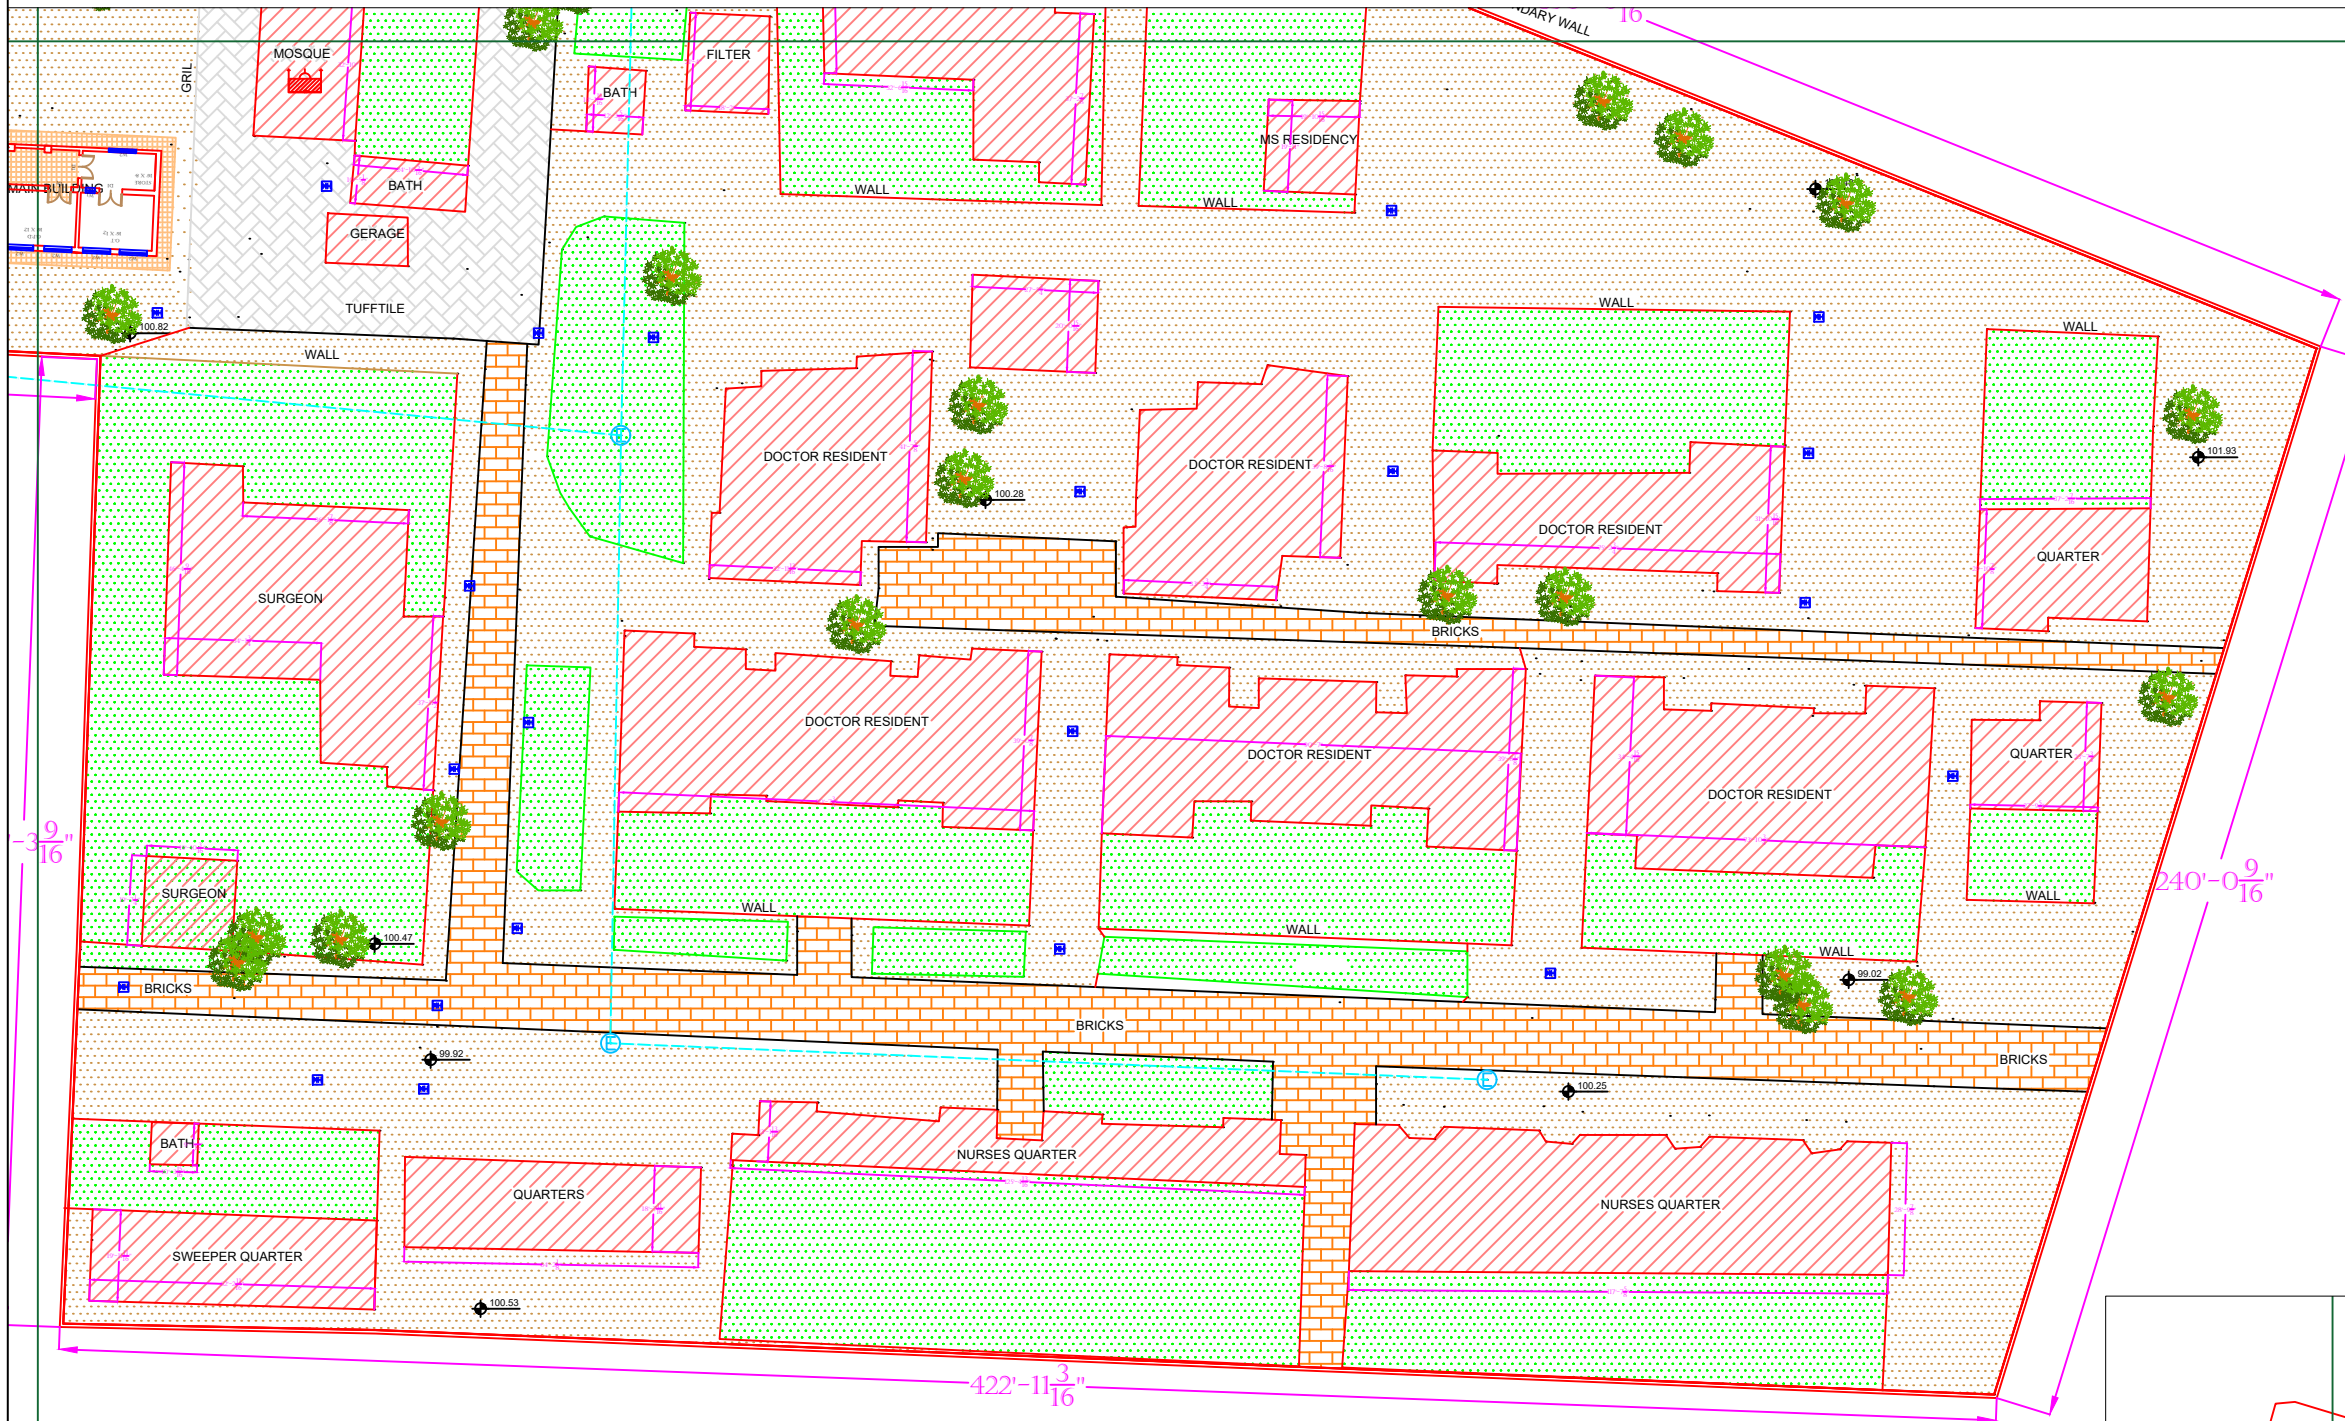


### Legends:

Residential Area	
Road	
Wall	
Power Line	
OHT	
Tree	
Man Hole	
Tube Well	
Light Pole	
Lawns	
Earthen Areas	
Asphalts Roads	
Tough Pavers	
P.C.C / Plinth Protection	
Boundary Wall	
Brick Pavers / Soling	
Drain	
Tap	
Hand Pump	
Air Conditioner	
Tube Light	
Fan	
Roof Light	
Bulb	

AREA	
AREA WITHIN BOUNDARY WALL	26650.859 SFT
AREA OF CLINICAL BLOCK	41470.792 SFT
PLINTH AREA OF BLOCK	32705.683 SFT

OPENING SCHEDULE OF DOORS AND WINDOWS					
DOORS	WIDTH	HEIGHT	WINDOWS	WIDTH	HEIGHT
D1	5'-0"	7'-0"	W1	3'-0"	3'-0"
D2	2'-6"	7'-0"	W2	6'-0"	6'-0"
D3	3'-6"	7'-0"	W3	8'-0"	8'-0"
D4	4'-0"	7'-0"			
D5	6'-0"	7'-0"			
D6	2'-0"	7'-0"			
D7	3'-0"	7'-0"			

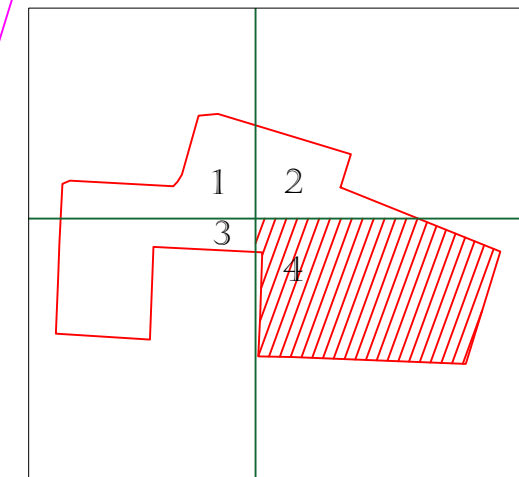

Project:  
**CAD MAPPING OF TEHSIL HEAD QUARTER HOSPITALS, PUNJAB**

Client: GOVERNMENT OF THE PUNJAB  
PRIMARY & SECONDARY HEALTHCARE DEPARTMENT

Consultant: SKAFS CONSULTANT (Pvt.) Limited  
ENGINEERING AND ENVIRONMENT CONSULTANT


Drawing Title:  
**THQ AHMAD PUR SIAL HOSPITAL MASTER PLAN PART 4**

Drawing No. **SKAFS/A-P-SIAL /07**




# CLINICAL BLOCK OF THQ HOSPITAL AHMAD PUR SIAL GROUND FLOOR


## PART 1

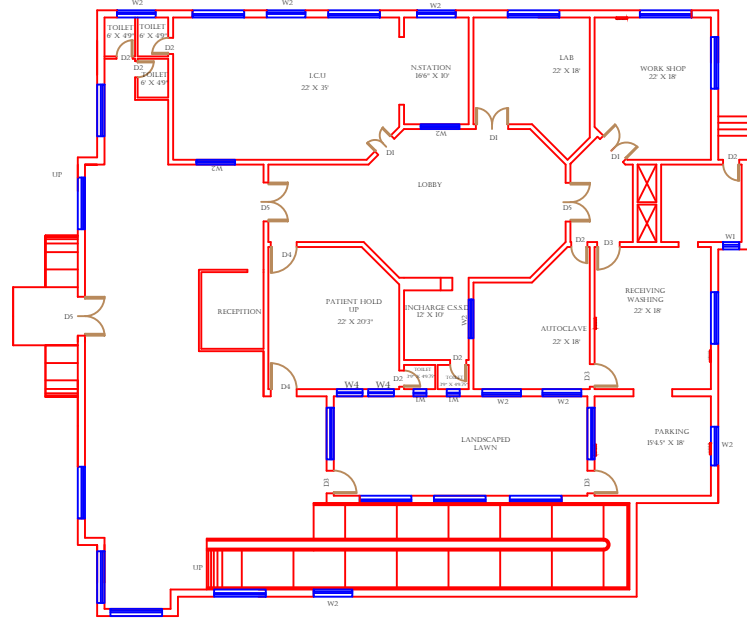


## PART 2

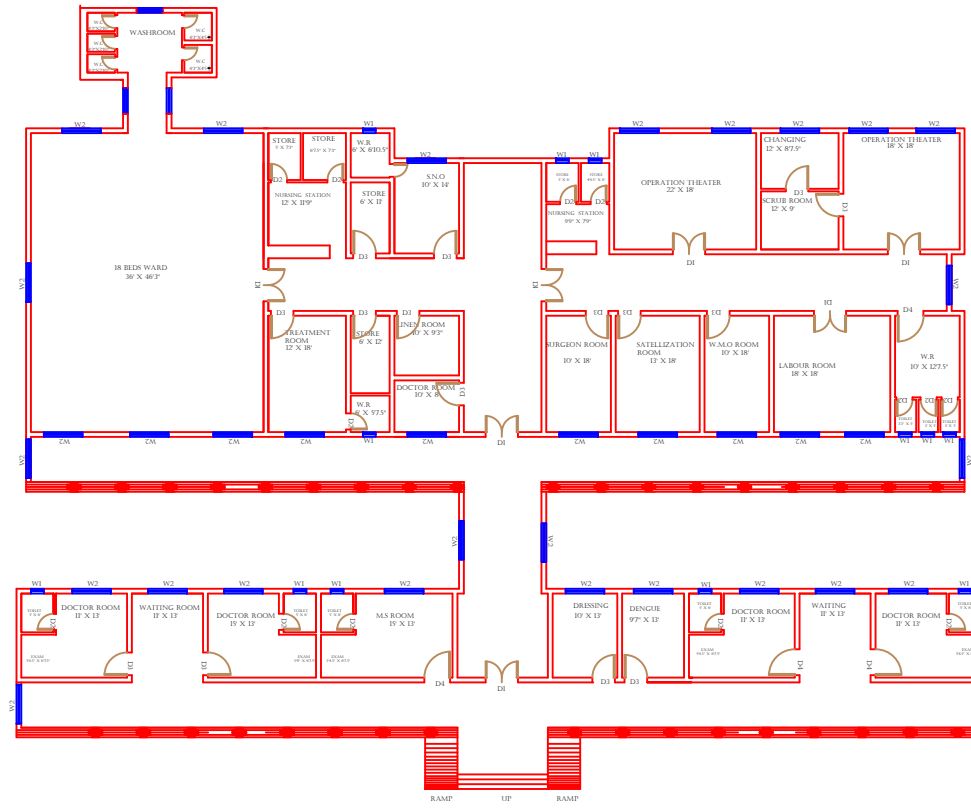

## PART 3

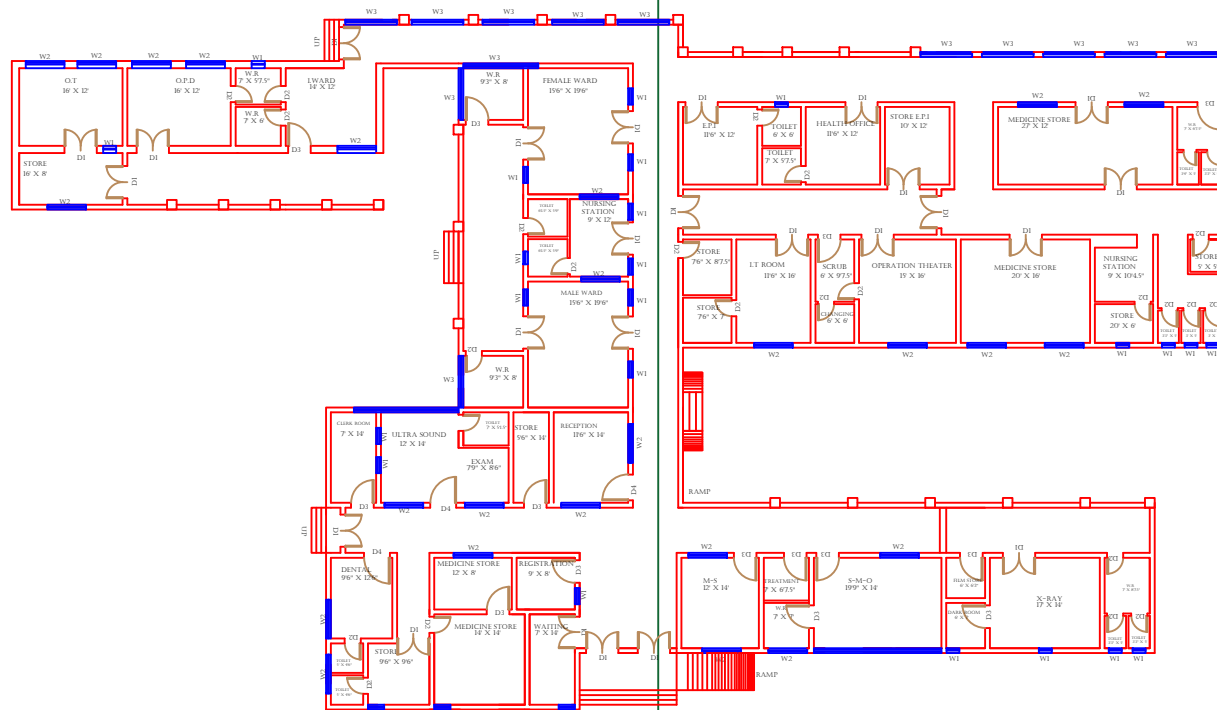

## PART 4

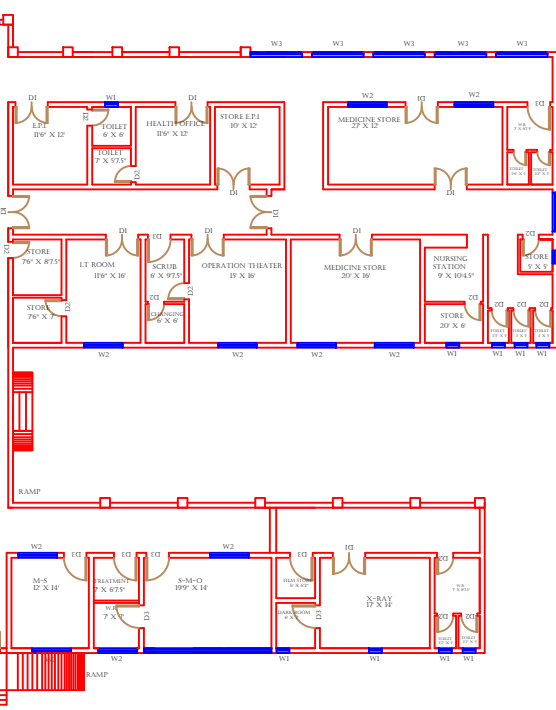

### Legends:

Residential Area	
Road	
Wall	
Power Line	
OHT	
Tree	
Man Hole	
Tube Well	
Light Pole	
Lawns	
Earthen Areas	
Asphalts Roads	
Tough Pavers	
P.C.C / Plinth Protection	
Boundary Wall	
Brick Pavers / Soling	
Drain	
Tap	
Hand Pump	
Air Conditioner	
Tube Light	
Fan	
Roof Light	
Bulb	

AREA	
AREA WITHIN BOUNDARY WALL	266550.859 SFT
AREA OF CLINICAL BLOCK	41470.792 SFT
PLINTH AREA OF BLOCK	32705.683 SFT

OPENING SCHEDULE OF DOORS AND WINDOWS					
DOORS	WIDTH	HEIGHT	WINDOWS	WIDTH	HEIGHT
D1	5'-0"	7'-0"	W1	3'-0"	3'-0"
D2	2'-6"	7'-0"	W2	6'-0"	6'-0"
D3	3'-6"	7'-0"	W3	8'-0"	8'-0"
D4	4'-0"	7'-0"			
D5	6'-0"	7'-0"			
D6	2'-0"	7'-0"			
D7	3'-0"	7'-0"			

Project:  
**CAD MAPPING OF TEHSIL  
HEAD QUARTER HOSPITALS,  
PUNJAB**

Client: GOVERNMENT OF THE PUNJAB  
PRIMARY & SECONDARY  
HEALTHCARE DEPARTMENT


Consultant: SKAFS CONSULTANT (Pvt.)  
Limited  
ENGINEERING AND ENVIRONMENT  
CONSULTANT

Drawing Title:  
**THQ AHMAD PUR SIAL  
HOSPITAL CLINICAL BLOCK PLAN**

Drawing No. **SKAFS/A-P-SIAL /08**

# CLINICAL BLOCK OF THQ HOSPITAL AHMAD PUR SIAL

## GROUND FLOOR PART 1

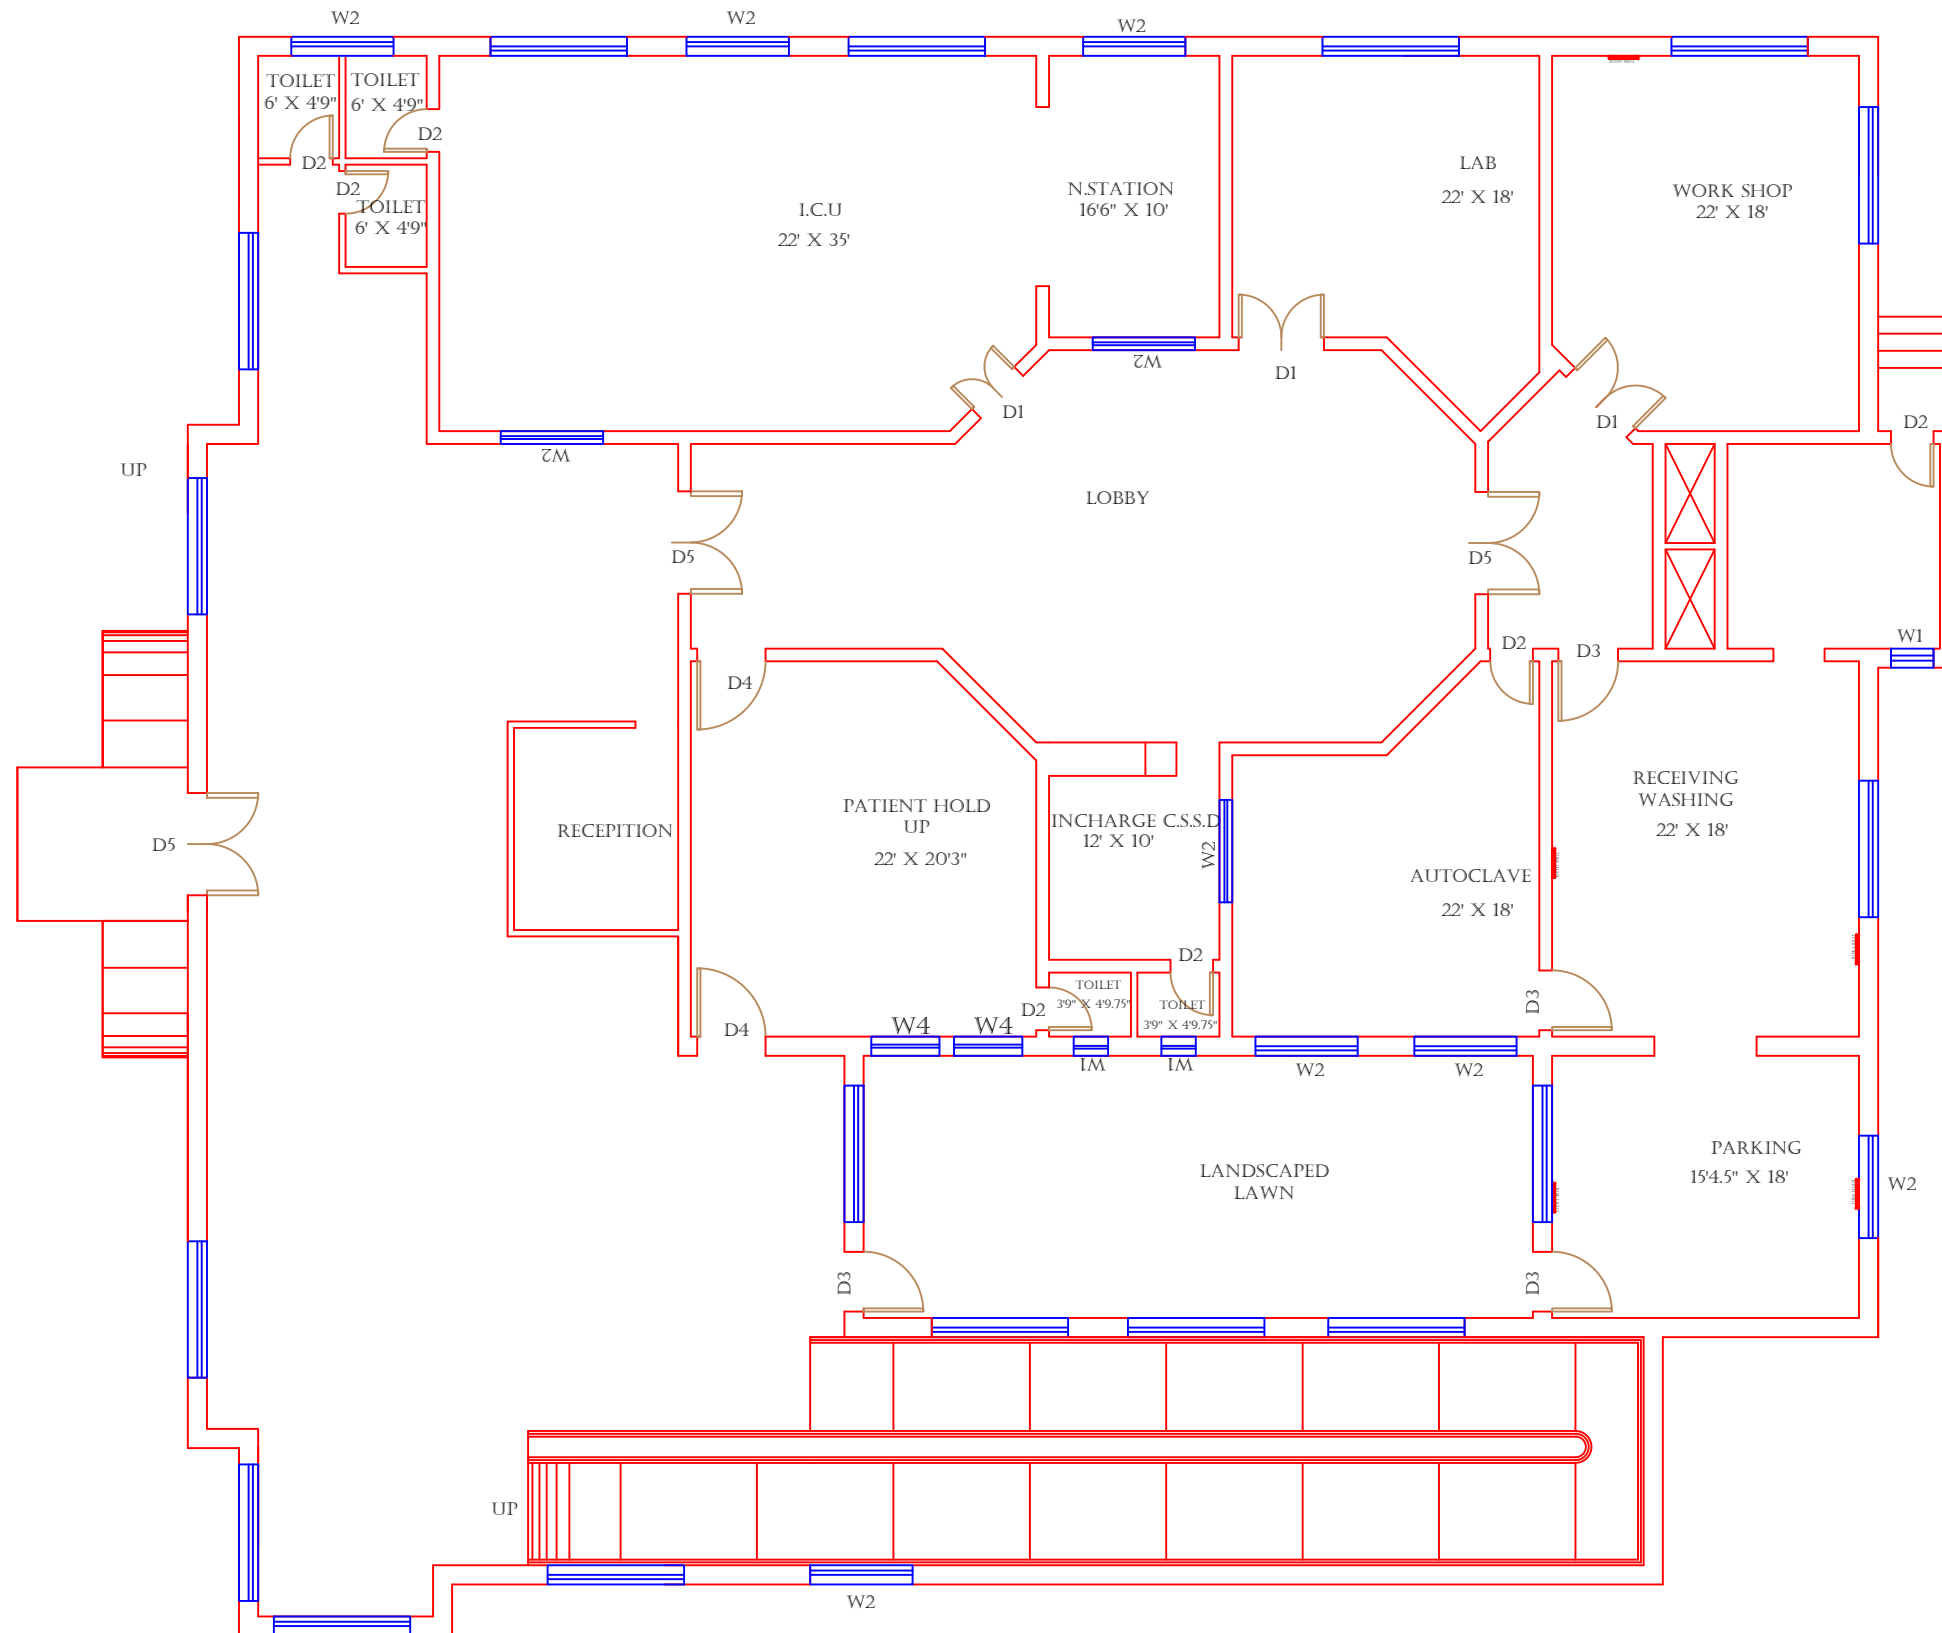

### Legends:

Residential Area	
Road	
Wall	
Power Line	
OHT	
Tree	
Man Hole	
Tube Well	
Light Pole	
Lawns	
Earthen Areas	
Asphalts Roads	
Tough Pavers	
P.C.C / Plinth Protection	
Boundary Wall	
Brick Pavers / Soling	
Drain	
Tap	
Hand Pump	
Air Conditioner	
Tube Light	
Fan	
Roof Light	
Bulb	

AREA	
AREA WITHIN BOUNDARY WALL	26650.859 SFT
AREA OF CLINICAL BLOCK	41470.792 SFT
PLINTH AREA OF BLOCK	32705.683 SFT

OPENING SCHEDULE OF DOORS AND WINDOWS					
DOORS	WIDTH	HEIGHT	WINDOWS	WIDTH	HEIGHT
D1	5'-0"	7'-0"	W1	3'-0"	3'-0"
D2	2'-6"	7'-0"	W2	6'-0"	6'-0"
D3	3'-6"	7'-0"	W3	8'-0"	8'-0"
D4	4'-0"	7'-0"			
D5	6'-0"	7'-0"			
D6	2'-0"	7'-0"			
D7	3'-0"	7'-0"			

Project:  
**CAD MAPPING OF TEHSIL HEAD QUARTER HOSPITALS, PUNJAB**

Client: GOVERNMENT OF THE PUNJAB  
PRIMARY & SECONDARY HEALTHCARE DEPARTMENT


Consultant: SKAFS CONSULTANT (Pvt.) Limited  
ENGINEERING AND ENVIRONMENT CONSULTANT

Drawing Title:  
**THQ AHMAD PUR SIAL CLINICAL BLOCK PLAN (PART 1)**

Drawing No. **SKAFS/A-P-SIAL /09**

# CLINICAL BLOCK OF THQ HOSPITAL AHMAD PUR SIAL

## GROUND FLOOR PART 2

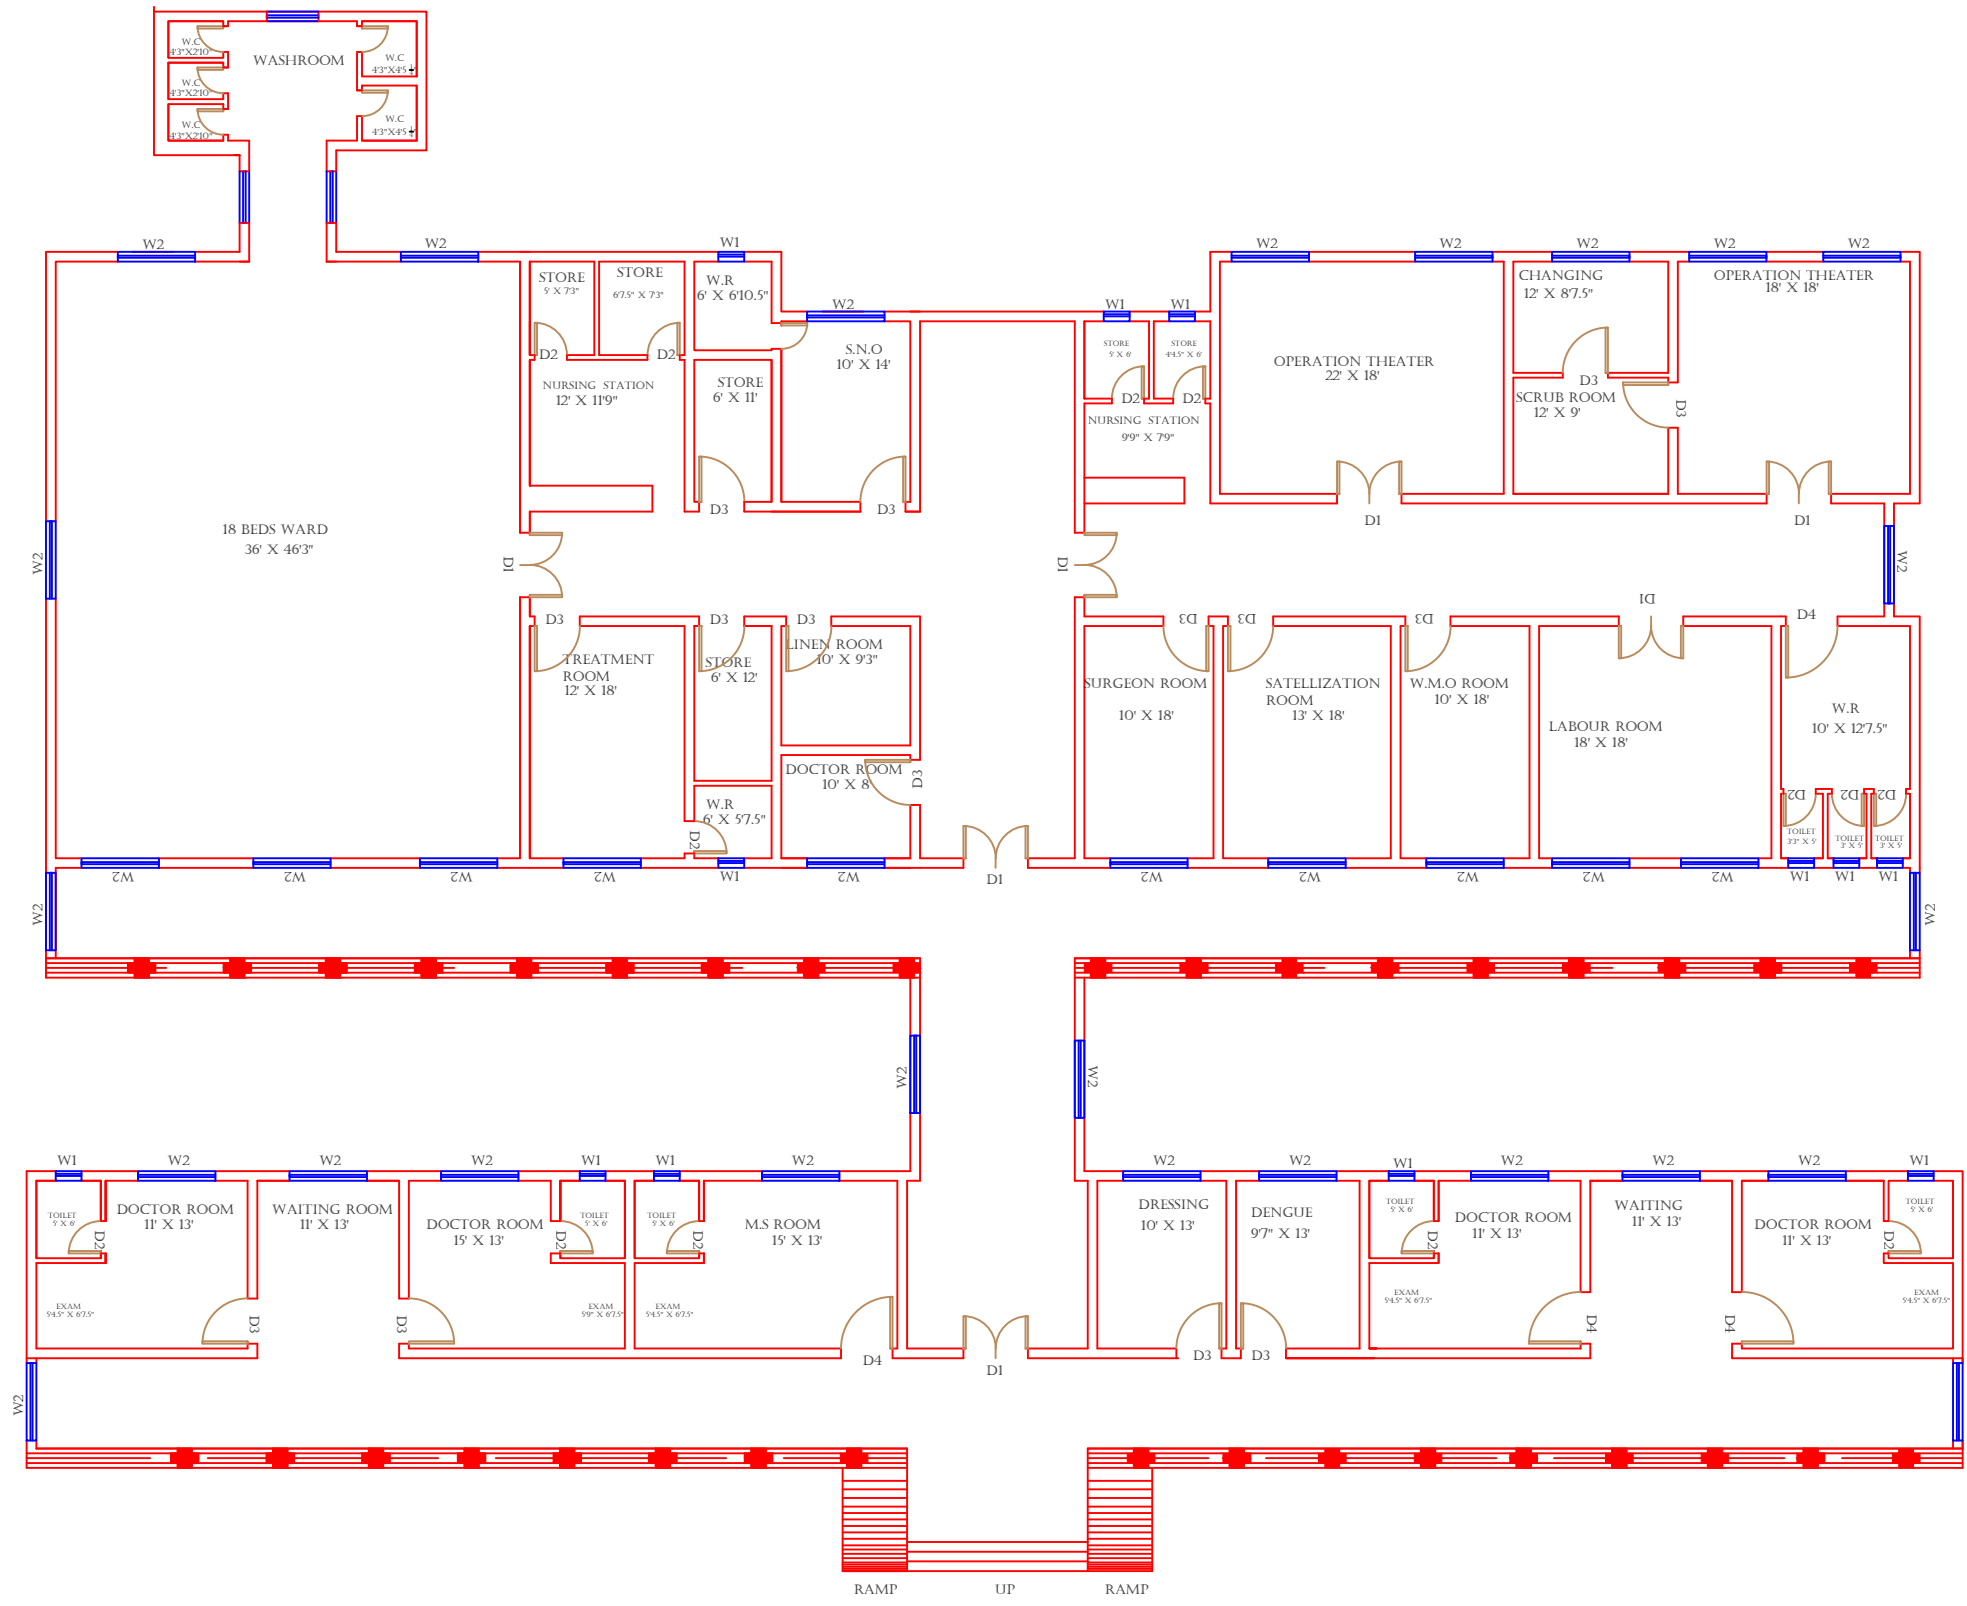

### Legends:

Residential Area	
Road	
Wall	
Power Line	
OHT	
Tree	
Man Hole	
Tube Well	
Light Pole	
Lawns	
Earthen Areas	
Asphalts Roads	
Tough Pavers	
P.C.C / Plinth Protection	
Boundary Wall	
Brick Pavers / Soling	
Drain	
Tap	
Hand Pump	
Air Conditioner	
Tube Light	
Fan	
Roof Light	
Bulb	

AREA	
AREA WITHIN BOUNDARY WALL	26650.859 SFT
AREA OF CLINICAL BLOCK	41470.792 SFT
PLINTH AREA OF BLOCK	32705.683 SFT

OPENING SCHEDULE OF DOORS AND WINDOWS					
DOORS	WIDTH	HEIGHT	WINDOWS	WIDTH	HEIGHT
D1	5'-0"	7'-0"	W1	3'-0"	3'-0"
D2	2'-6"	7'-0"	W2	6'-0"	6'-0"
D3	3'-6"	7'-0"	W3	8'-0"	8'-0"
D4	4'-0"	7'-0"			
D5	6'-0"	7'-0"			
D6	2'-0"	7'-0"			
D7	3'-0"	7'-0"			

Project:  
**CAD MAPPING OF TEHSIL HEAD QUARTER HOSPITALS, PUNJAB**


Client:  GOVERNMENT OF THE PUNJAB PRIMARY & SECONDARY HEALTHCARE DEPARTMENT	Consultant:  SKAFS CONSULTANT (Pvt.) Limited ENGINEERING AND ENVIRONMENT CONSULTANT
---	--

Drawing Title:  
**THQ AHMAD PUR SIAL  
CLINICAL BLOCK PLAN (PART 2)**



# CLINICAL BLOCK OF THQ HOSPITAL AHMAD PUR SIAL

## GROUND FLOOR PART 3

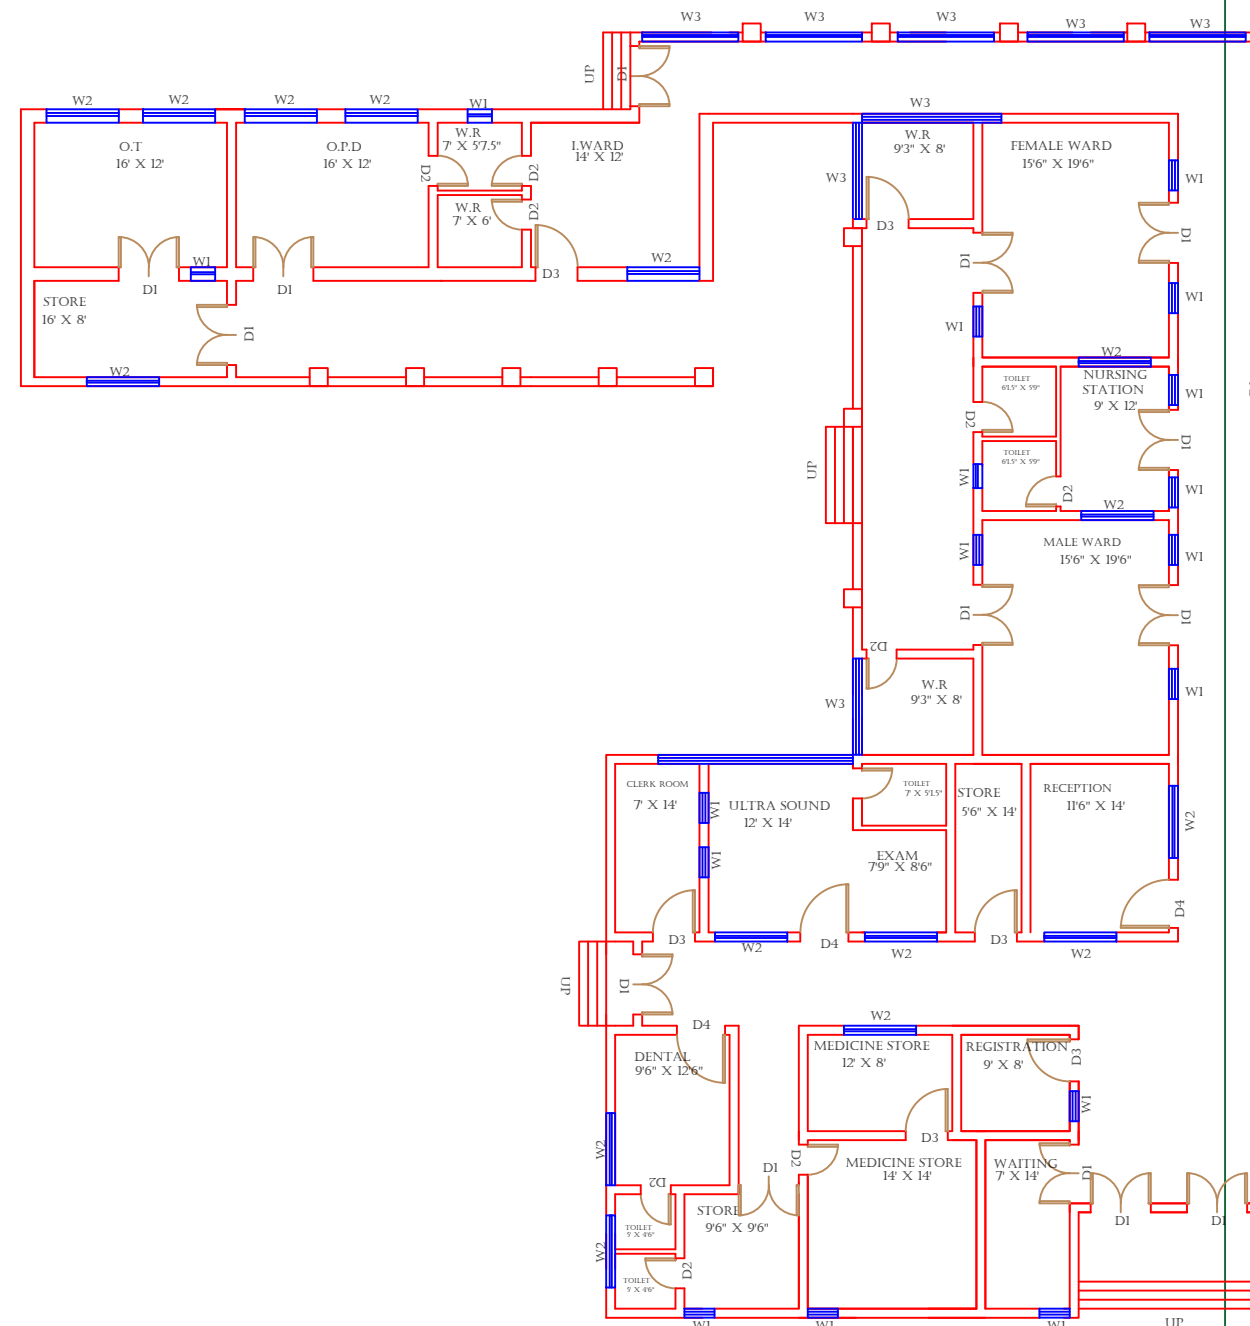

### Legends:

Residential Area	
Road	
Wall	
Power Line	
OHT	
Tree	
Man Hole	
Tube Well	
Light Pole	
Lawns	
Earthen Areas	
Asphalts Roads	
Tough Pavers	
P.C.C / Plinth Protection	
Boundary Wall	
Brick Pavers / Soling	
Drain	
Tap	
Hand Pump	
Air Conditioner	
Tube Light	
Fan	
Roof Light	
Bulb	

AREA	
AREA WITHIN BOUNDARY WALL	266550.859 SFT
AREA OF CLINICAL BLOCK	41470.792 SFT
PLINTH AREA OF BLOCK	32705.683 SFT

### OPENING SCHEDULE OF DOORS AND WINDOWS

DOORS	WIDTH	HEIGHT	WINDOWS	WIDTH	HEIGHT
D1	5'-0"	7'-0"	W1	3'-0"	3'-0"
D2	2'-6"	7'-0"	W2	6'-0"	6'-0"
D3	3'-6"	7'-0"	W3	8'-0"	8'-0"
D4	4'-0"	7'-0"			
D5	6'-0"	7'-0"			
D6	2'-0"	7'-0"			
D7	3'-0"	7'-0"			

Project:  
**CAD MAPPING OF TEHSIL HEAD QUARTER HOSPITALS, PUNJAB**

Client: GOVERNMENT OF THE PUNJAB  
PRIMARY & SECONDARY HEALTHCARE DEPARTMENT


Consultant: SKAFS CONSULTANT (Pvt.) Limited  
ENGINEERING AND ENVIRONMENT CONSULTANT

Drawing Title:  
**THQ AHMAD PUR SIAL CLINICAL BLOCK PLAN (PART 3)**

Drawing No. **SKAFS/A-P-SIAL /11**

# CLINICAL BLOCK OF THQ HOSPITAL AHMAD PUR SIAL

## GROUND FLOOR PART 4

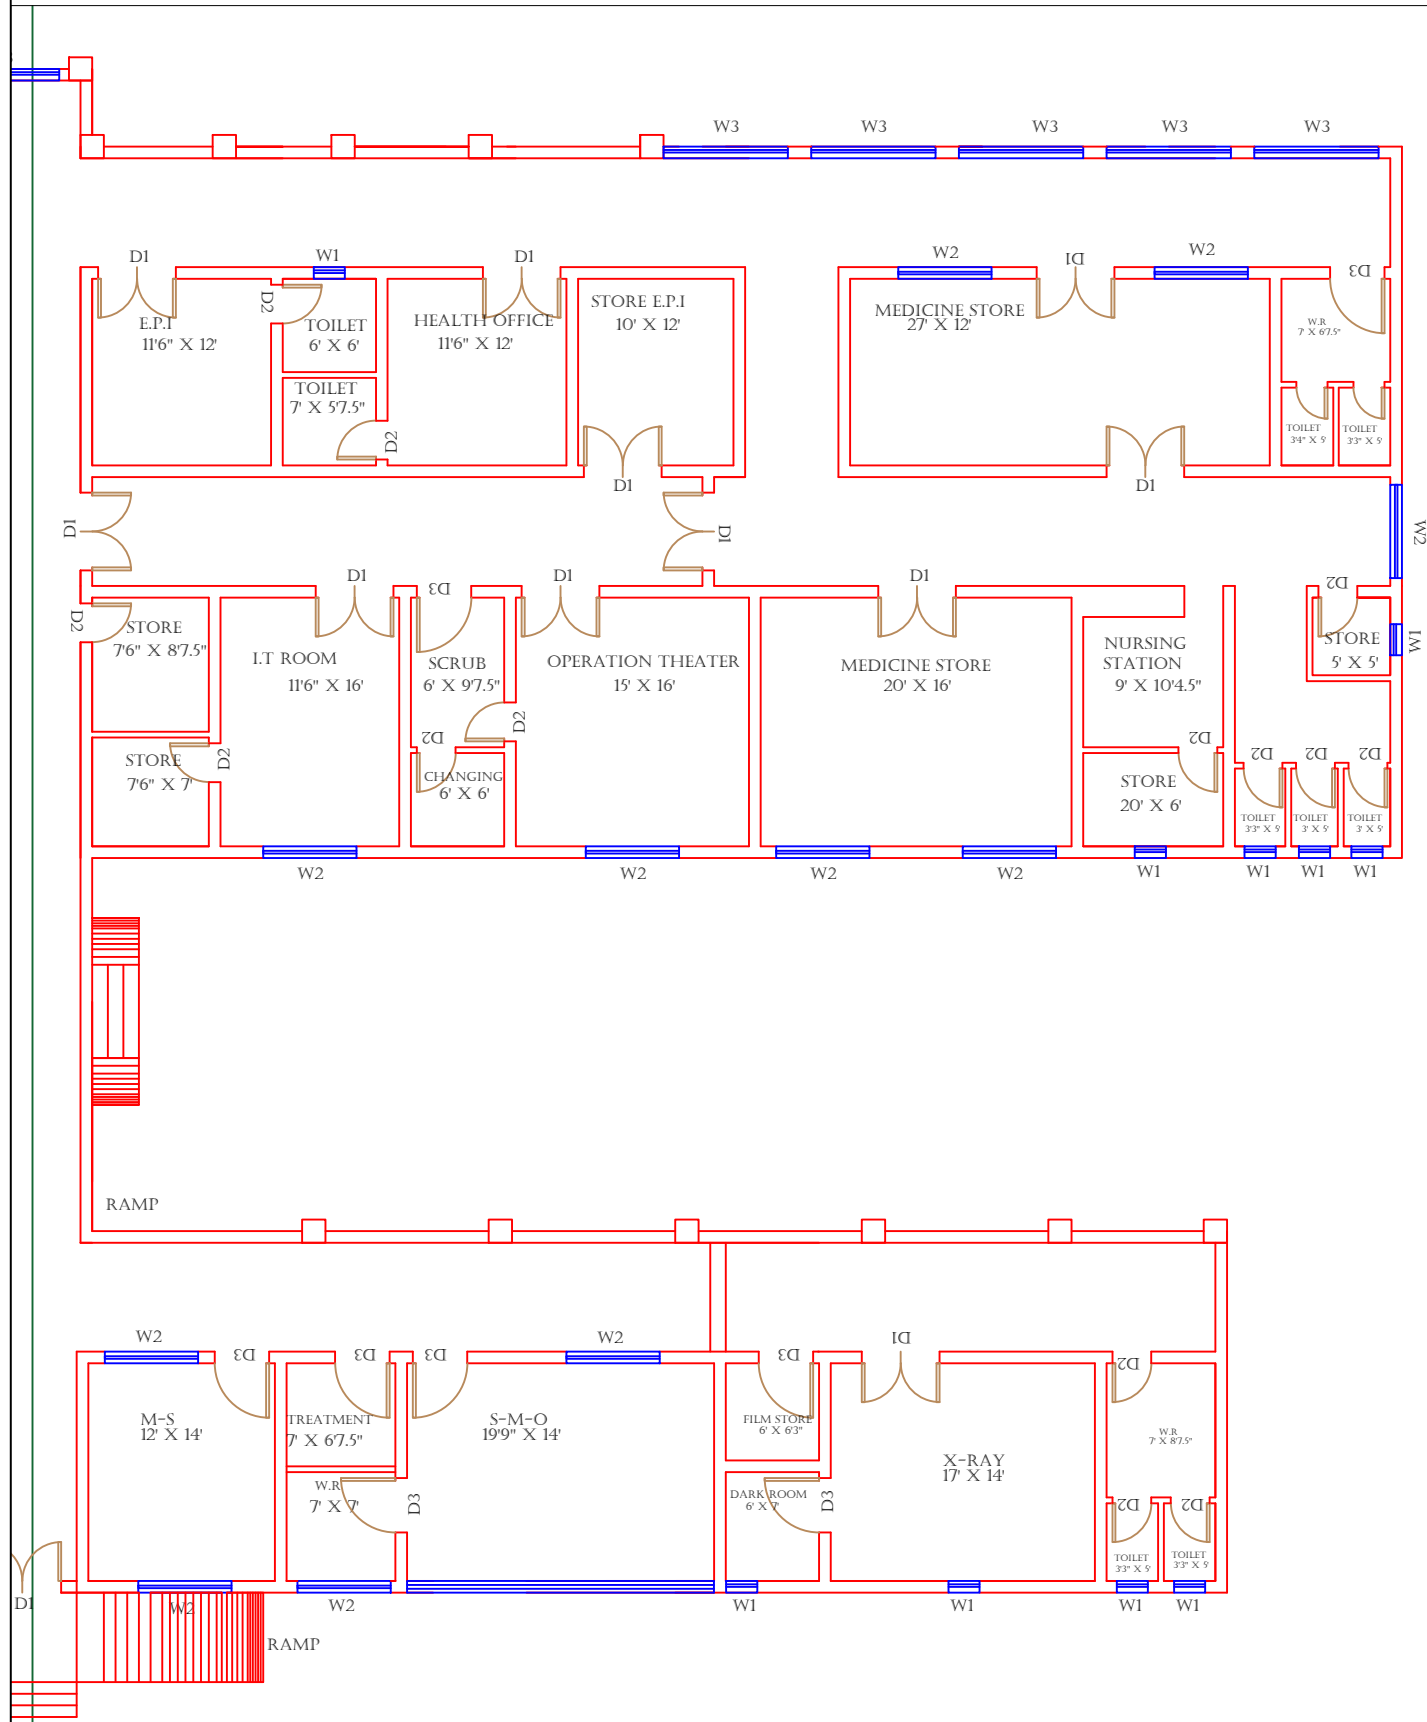

### Legends:

Residential Area	
Road	
Wall	
Power Line	
OHT	
Tree	
Man Hole	
Tube Well	
Light Pole	
Lawns	
Earthen Areas	
Asphalts Roads	
Tough Pavers	
P.C.C / Plinth Protection	
Boundary Wall	
Brick Pavers / Soling	
Drain	
Tap	
Hand Pump	
Air Conditioner	
Tube Light	
Fan	
Roof Light	
Bulb	

### AREA

AREA WITHIN BOUNDARY WALL	266550.859 SFT
AREA OF CLINICAL BLOCK	41470.792 SFT
PLINTH AREA OF BLOCK	32705.683 SFT

### OPENING SCHEDULE OF DOORS AND WINDOWS

DOORS	WIDTH	HEIGHT	WINDOWS	WIDTH	HEIGHT
D1	5'-0"	7'-0"	W1	3'-0"	3'-0"
D2	2'-6"	7'-0"	W2	6'-0"	6'-0"
D3	3'-6"	7'-0"	W3	8'-0"	8'-0"
D4	4'-0"	7'-0"			
D5	6'-0"	7'-0"			
D6	2'-0"	7'-0"			
D7	3'-0"	7'-0"			

Project:  
**CAD MAPPING OF TEHSIL HEAD QUARTER HOSPITALS, PUNJAB**


Client: GOVERNMENT OF THE PUNJAB  
PRIMARY & SECONDARY HEALTHCARE DEPARTMENT

Consultant: SKAFS CONSULTANT (Pvt.) Limited  
ENGINEERING AND ENVIRONMENT CONSULTANT

Drawing Title:  
**THQ AHMAD PUR SIAL CLINICAL BLOCK PLAN (PART 4)**

Drawing No. **SKAFS/A-P-SIAL /12**

# CLINICAL BLOCK OF THQ HOSPITAL AHMAD PUR SIAL FIRST FLOOR

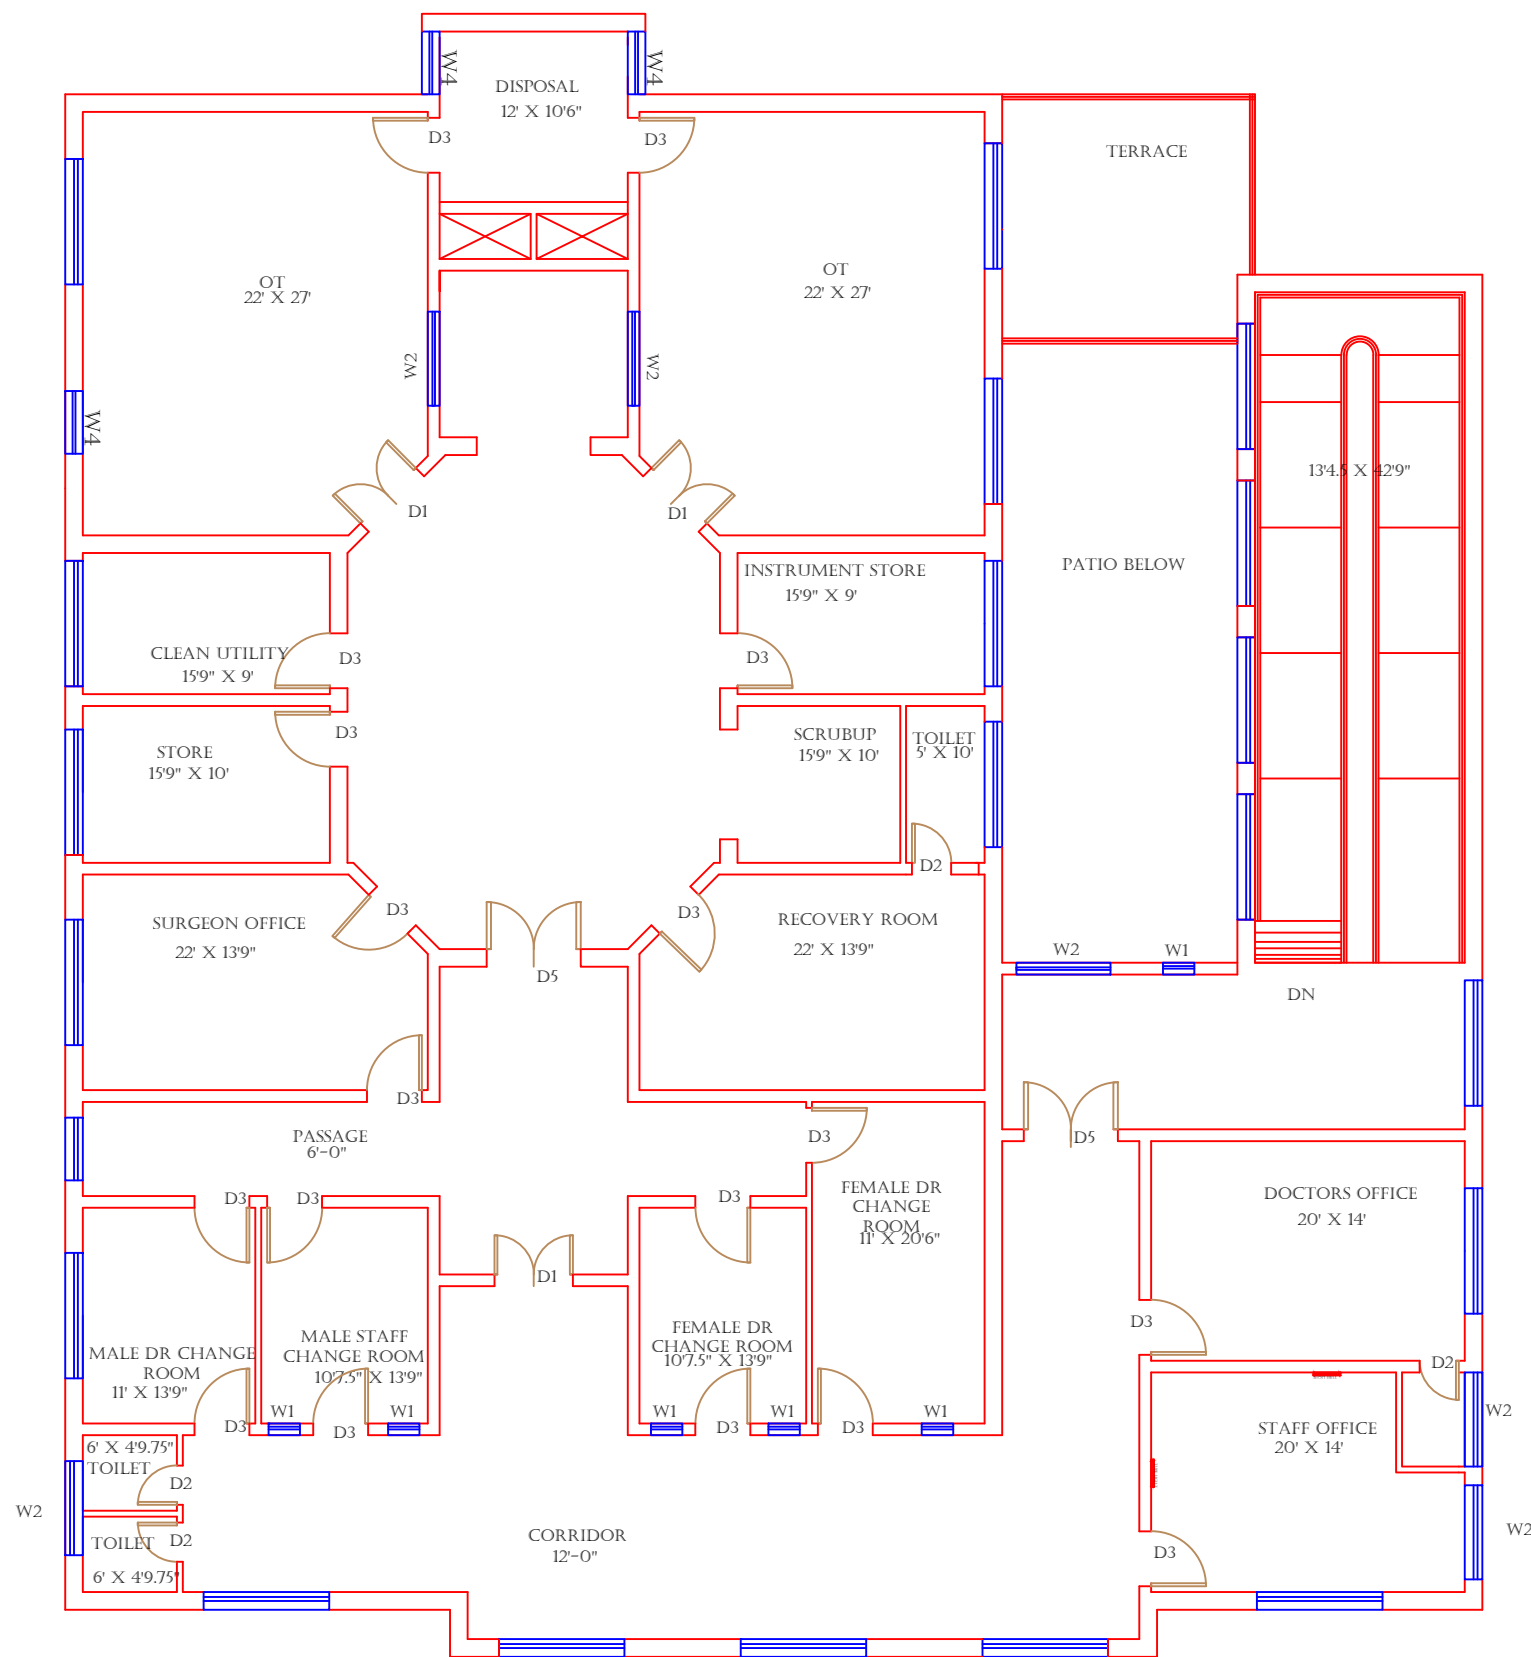

## Legends:

Residential Area	
Road	
Wall	
Power Line	
OHT	
Tree	
Man Hole	
Tube Well	
Light Pole	
Lawns	
Earthen Areas	
Asphalts Roads	
Tough Pavers	
P.C.C / Plinth Protection	
Boundary Wall	
Brick Pavers / Soling	
Drain	
Tap	
Hand Pump	
Air Conditioner	
Tube Light	
Fan	
Roof Light	
Bulb	

AREA	
AREA WITHIN BOUNDARY WALL	26650.859 SFT
AREA OF CLINICAL BLOCK	41470.792 SFT
PLINTH AREA OF BLOCK	32705.683 SFT

OPENING SCHEDULE OF DOORS AND WINDOWS						
DOORS	WIDTH	HEIGHT	WINDOWS	WIDTH	HEIGHT	
D1	5'-0"	7'-0"	W1	3'-0"	3'-0"	
D2	2'-6"	7'-0"	W2	6'-0"	6'-0"	
D3	3'-6"	7'-0"	W3	8'-0"	8'-0"	
D4	4'-0"	7'-0"				
D5	6'-0"	7'-0"				
D6	2'-0"	7'-0"				
D7	3'-0"	7'-0"				

Project:  
**CAD MAPPING OF TEHSIL  
HEAD QUARTER HOSPITALS,  
PUNJAB**



Client:  GOVERNMENT OF THE PUNJAB PRIMARY & SECONDARY HEALTHCARE DEPARTMENT	Consultant:  SKAFS CONSULTANT (Pvt.) Limited ENGINEERING AND ENVIRONMENT CONSULTANT
---	--

Drawing Title:  
**THQ AHMAD PUR SIAL  
FIRST FLOOR PLAN**

Drawing No. **SKAFS/A-P-SIAL /13**



# ELECTRICAL LAYOUT PLAN OF THQ HOSPITAL AHMAD PUR SIAL GROUND FLOOR

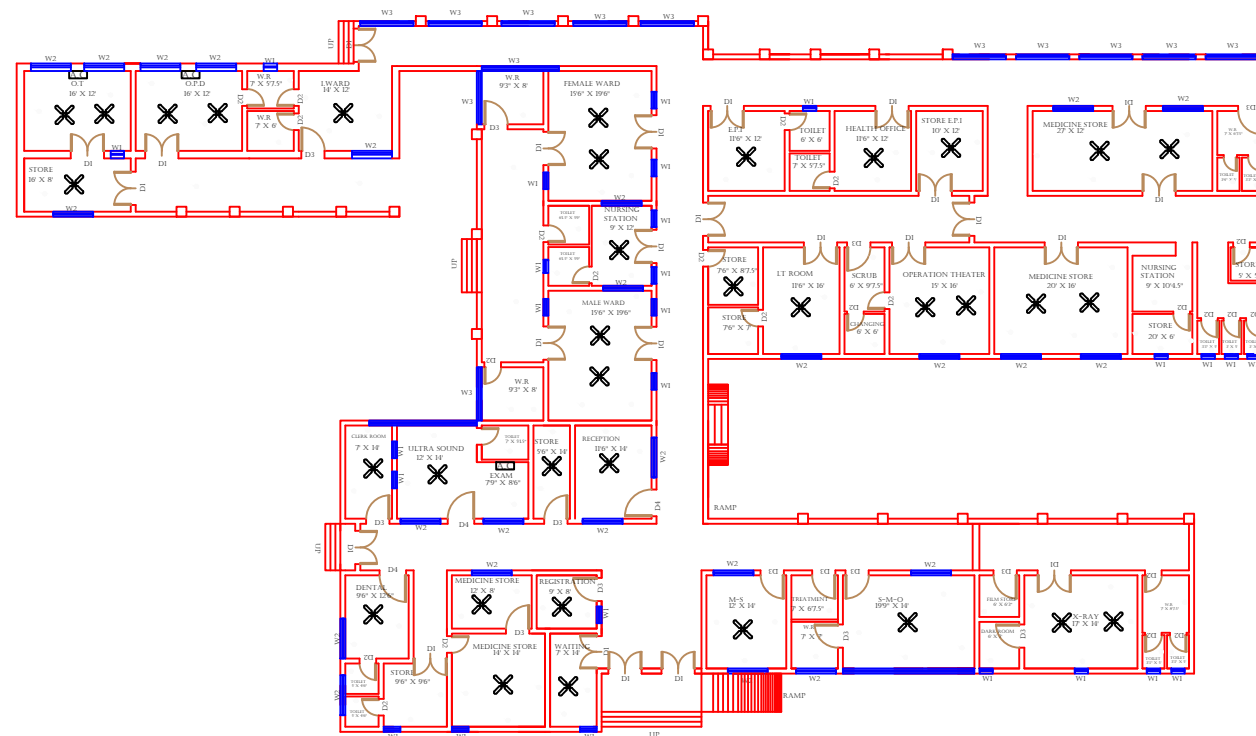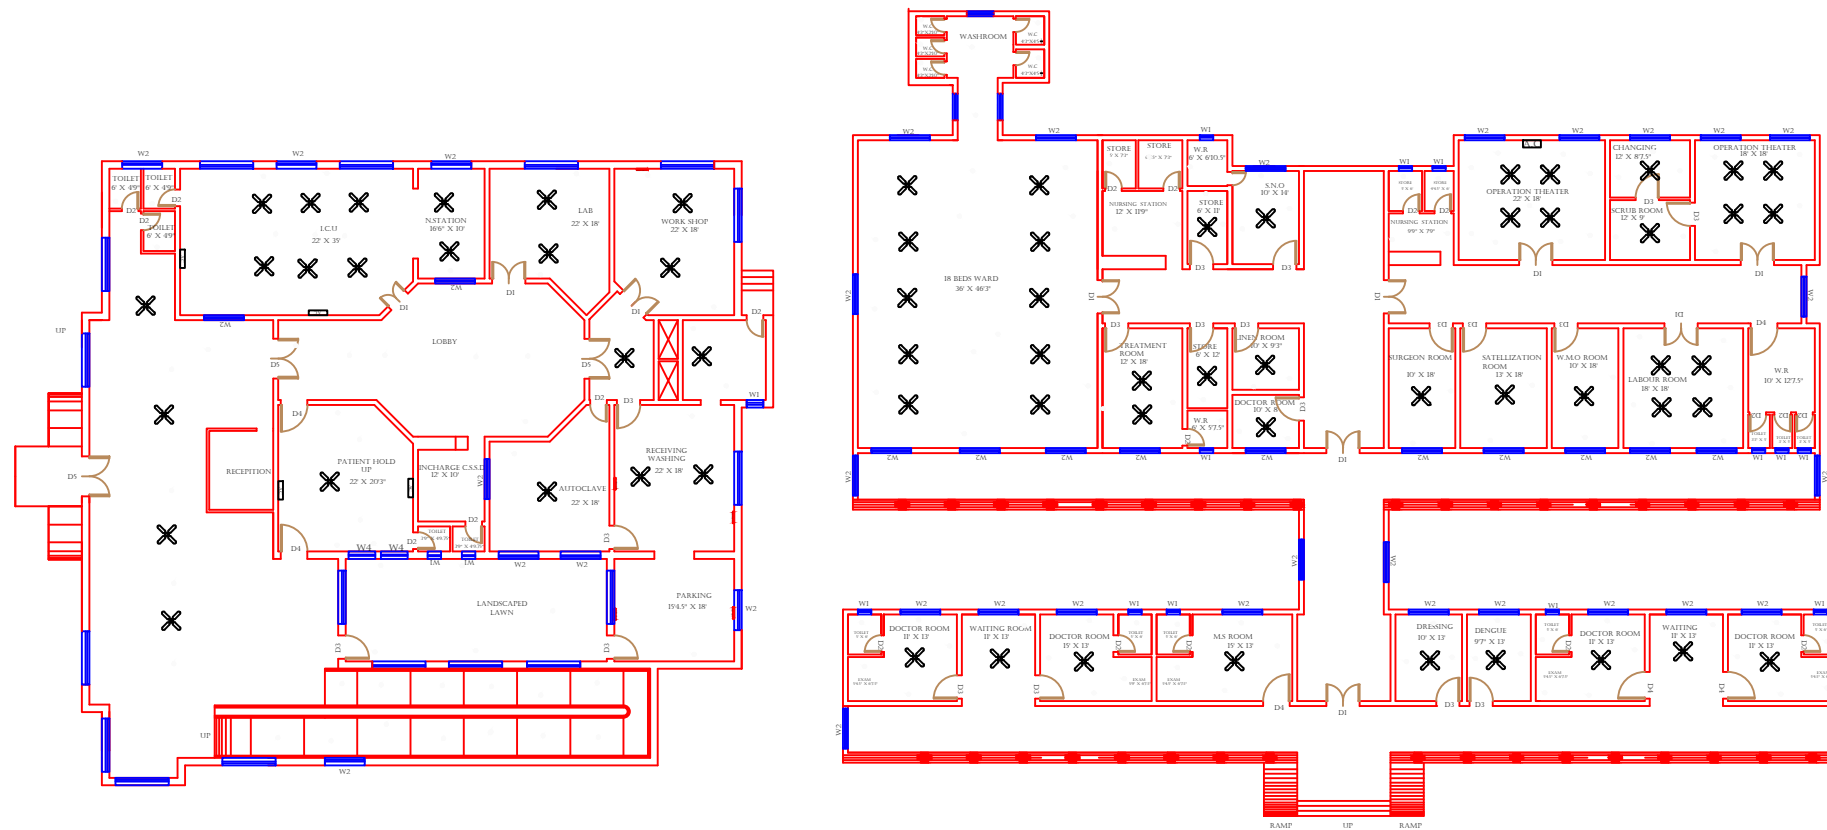

## Legends:

Residential Area	
Road	
Wall	
Power Line	
OHT	
Tree	
Man Hole	
Tube Well	
Light Pole	
Lawns	
Earthen Areas	
Asphalts Roads	
Tough Pavers	
P.C.C / Plinth Protection	
Boundary Wall	
Brick Pavers / Soling	
Drain	
Tap	
Hand Pump	
Air Conditioner	
Tube Light	
Fan	
Roof Light	
Bulb	

AREA	
AREA WITHIN BOUNDARY WALL	266550.859 SFT
AREA OF CLINICAL BLOCK	41470.792 SFT
PLINTH AREA OF BLOCK	32705.683 SFT

OPENING SCHEDULE OF DOORS AND WINDOWS					
DOORS	WIDTH	HEIGHT	WINDOWS	WIDTH	HEIGHT
D1	5'-0"	7'-0"	W1	3'-0"	3'-0"
D2	2'-6"	7'-0"	W2	6'-0"	6'-0"
D3	3'-6"	7'-0"	W3	8'-0"	8'-0"
D4	4'-0"	7'-0"			
D5	6'-0"	7'-0"			
D6	2'-0"	7'-0"			
D7	3'-0"	7'-0"			

Project:  
**CAD MAPPING OF TEHSIL  
HEAD QUARTER HOSPITALS,  
PUNJAB**


Client: GOVERNMENT OF THE PUNJAB  
PRIMARY & SECONDARY  
HEALTHCARE DEPARTMENT

Consultant: SKAFS CONSULTANT (Pvt.)  
Limited  
ENGINEERING AND ENVIRONMENT  
CONSULTANT

Drawing Title:  
**THQ AHMAD PUR SIAL  
ELECTRICAL PLAN (GROUND FLOOR)**

Drawing No. **SKAFS/A-P-SIAL /14**

# ELECTRICAL LAYOUT PLAN OF THQ HOSPITAL AHMAD PUR SIAL FIRST FLOOR

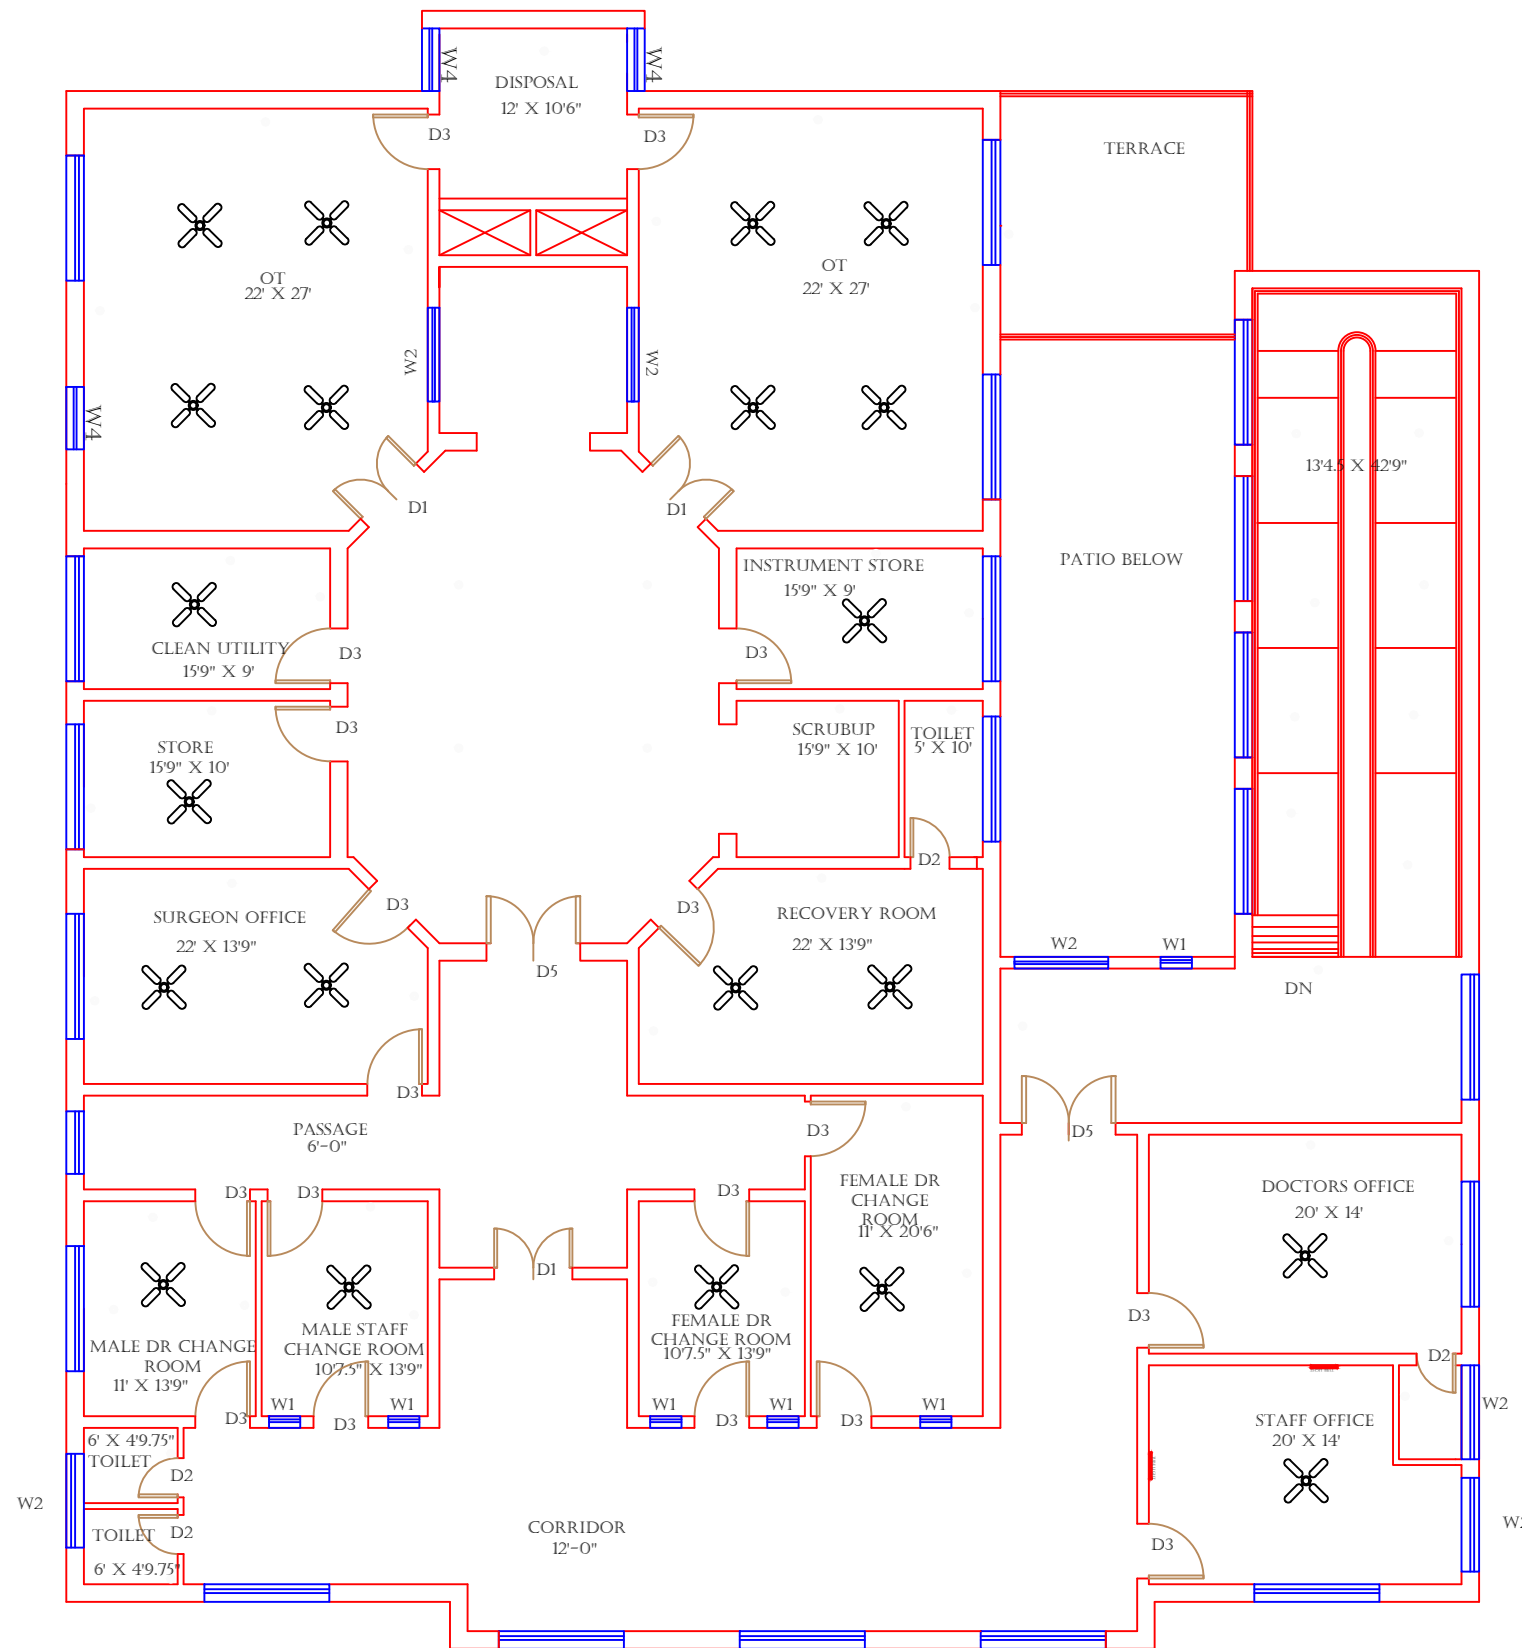

## Legends:

Residential Area	
Road	
Wall	
Power Line	
OHT	
Tree	
Man Hole	
Tube Well	
Light Pole	
Lawns	
Earthen Areas	
Asphalts Roads	
Tough Pavers	
P.C.C / Plinth Protection	
Boundary Wall	
Brick Pavers / Soling	
Drain	
Tap	
Hand Pump	
Air Conditioner	
Tube Light	
Fan	
Roof Light	
Bulb	

AREA	
AREA WITHIN BOUNDARY WALL	266550.859 SFT
AREA OF CLINICAL BLOCK	41470.792 SFT
PLINTH AREA OF BLOCK	32705.683 SFT

OPENING SCHEDULE OF DOORS AND WINDOWS					
DOORS	WIDTH	HEIGHT	WINDOWS	WIDTH	HEIGHT
D1	5'-0"	7'-0"	W1	3'-0"	3'-0"
D2	2'-6"	7'-0"	W2	6'-0"	6'-0"
D3	3'-6"	7'-0"	W3	8'-0"	8'-0"
D4	4'-0"	7'-0"			
D5	6'-0"	7'-0"			
D6	2'-0"	7'-0"			
D7	3'-0"	7'-0"			

Project:  
**CAD MAPPING OF TEHSIL  
HEAD QUARTER HOSPITALS,  
PUNJAB**

Client:  GOVERNMENT OF THE PUNJAB PRIMARY & SECONDARY HEALTHCARE DEPARTMENT	Consultant:  SKAFS CONSULTANT (Pvt.) Limited ENGINEERING AND ENVIRONMENT CONSULTANT
---	--

Drawing Title:  
**THQ AHMAD PUR SIAL  
ELECTRICAL PLAN (FIRST FLOOR)**

Drawing No.  
**SKAFS/A-P-SIAL /15**