

# MASTER PLAN OF THQ HOSPITAL BHERA


PART 1

PART 2



PART 3

PART 4

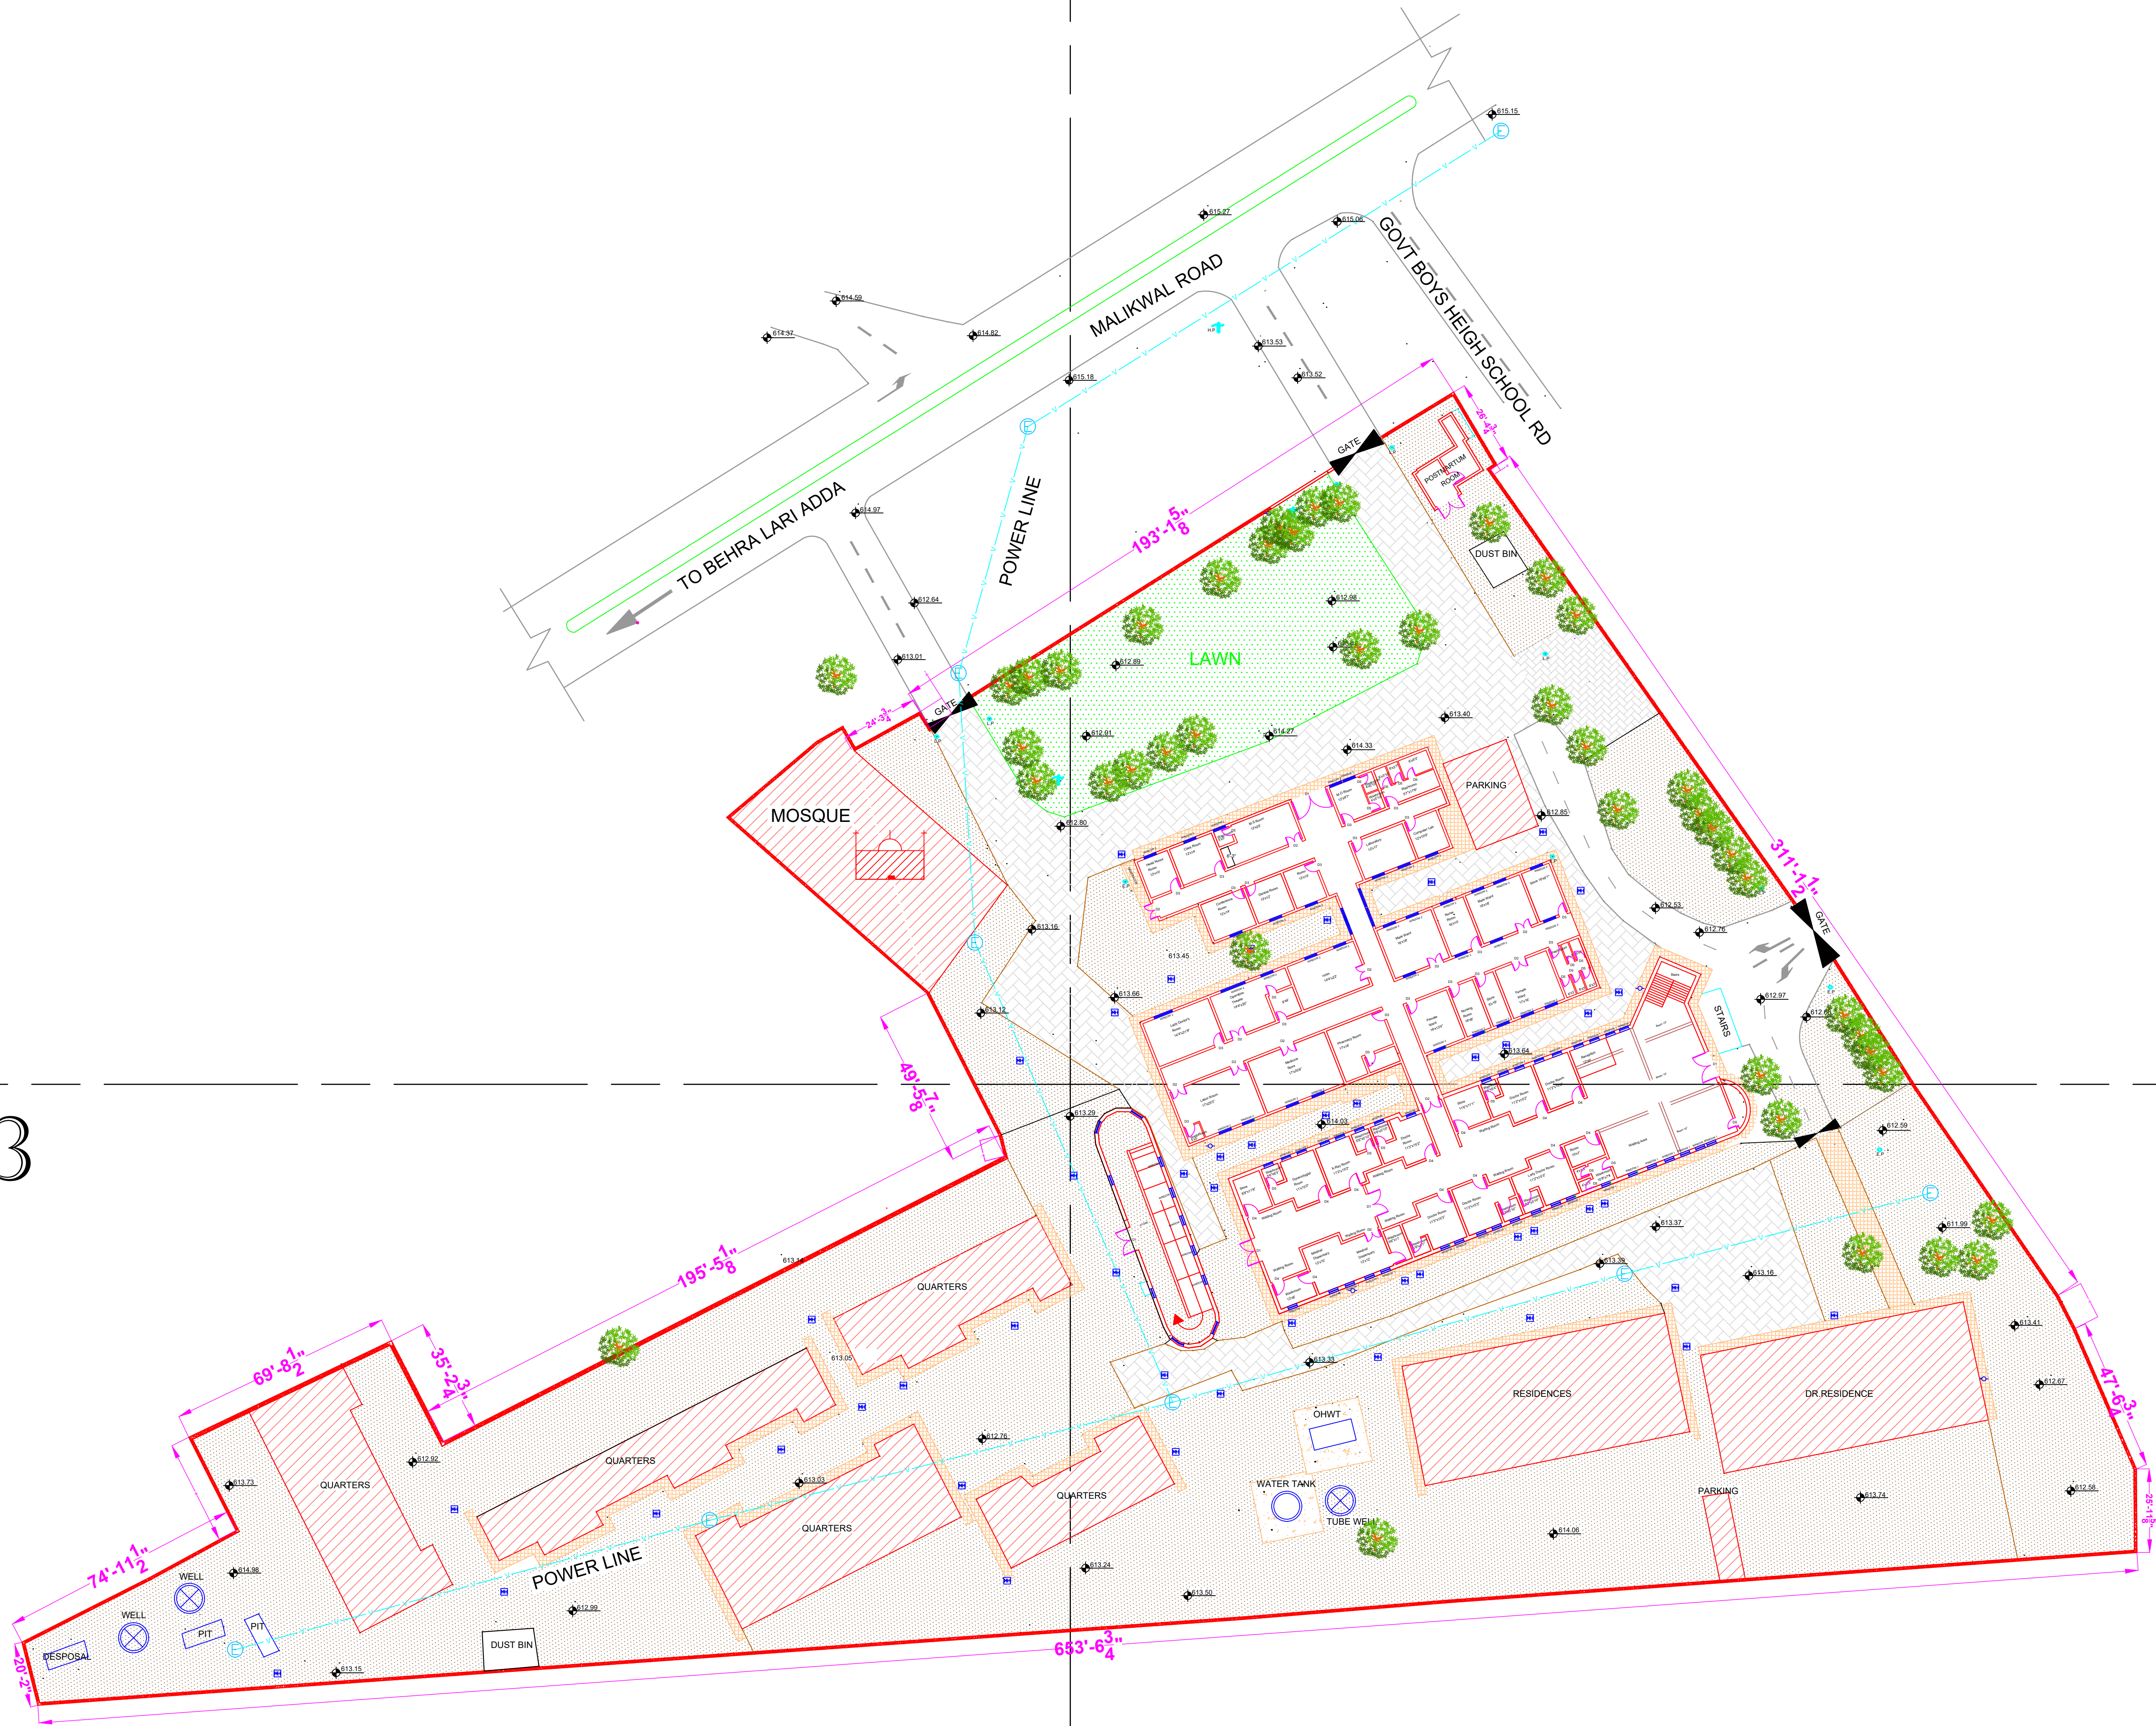

Legends:

Residential Area	
Road	
Wall	
Power Line	
OHT	
Tree	
ManHole	
Tube Well	
Light Pole	
Lawns	
Earthen Areas	
Asphalts Roads	
Tough Pavers	
P.C.C./Plinth Protection	
Boundary Wall	
Tap	
Hand Pump	
BRICK Pavers	
Air Conditioner	
Tube Light	
Fan	
Roof Light	
Bulb	

AREA	
AREA WITHIN BOUNDARY WALL	122241.3 Sft
AREA OF CLINICAL BLOCK	30403.64 Sft
PLINTH AREA OF BLOCK	23313.64 Sft

OPENING SCHEDULE OF DOORS AND WINDOWS					
DOORS	WIDTH	HEIGHT	WINDOWS	WIDTH	HEIGHT
D1	8'-0"	7'-0"	W1	3'-0"	5'-0"
D2	4'-6"	7'-0"	W2	4'-0"	4'-0"
D3	3'-0"	7'-0"	W3		
D4	3'-6"	7'-0"	W4		
D5	2'-6"	7'-0"	W5		
D6			W6		
D7			W7		
D8			V1		
D9			V2		

Client:



GOVERNMENT OF THE PUNJAB  
PRIMARY & SECONDARY  
HEALTHCARE DEPARTMENT

Project:

CAD MAPPING OF TEHSIL  
HEAD QUARTER HOSPITALS,  
PUNJAB

Consultant:



SKAFS CONSULTANT (Pvt.) Limited  
ENGINEERING AND ENVIRONMENT CONSULTANT

Drawing Title:


THQ MAILSI  
HOSPITAL MASTER PLAN

Authorized By: SKAFS	Reviewed By Co-Team Leader	Scale: 1:300
Prepared By: CAD TEAMS	Date: FEB, 2017	
Drawing No.		SKAFS/BHERA /03



# MASTER PLAN OF THQ HOSPITAL BHERA

## PART 1

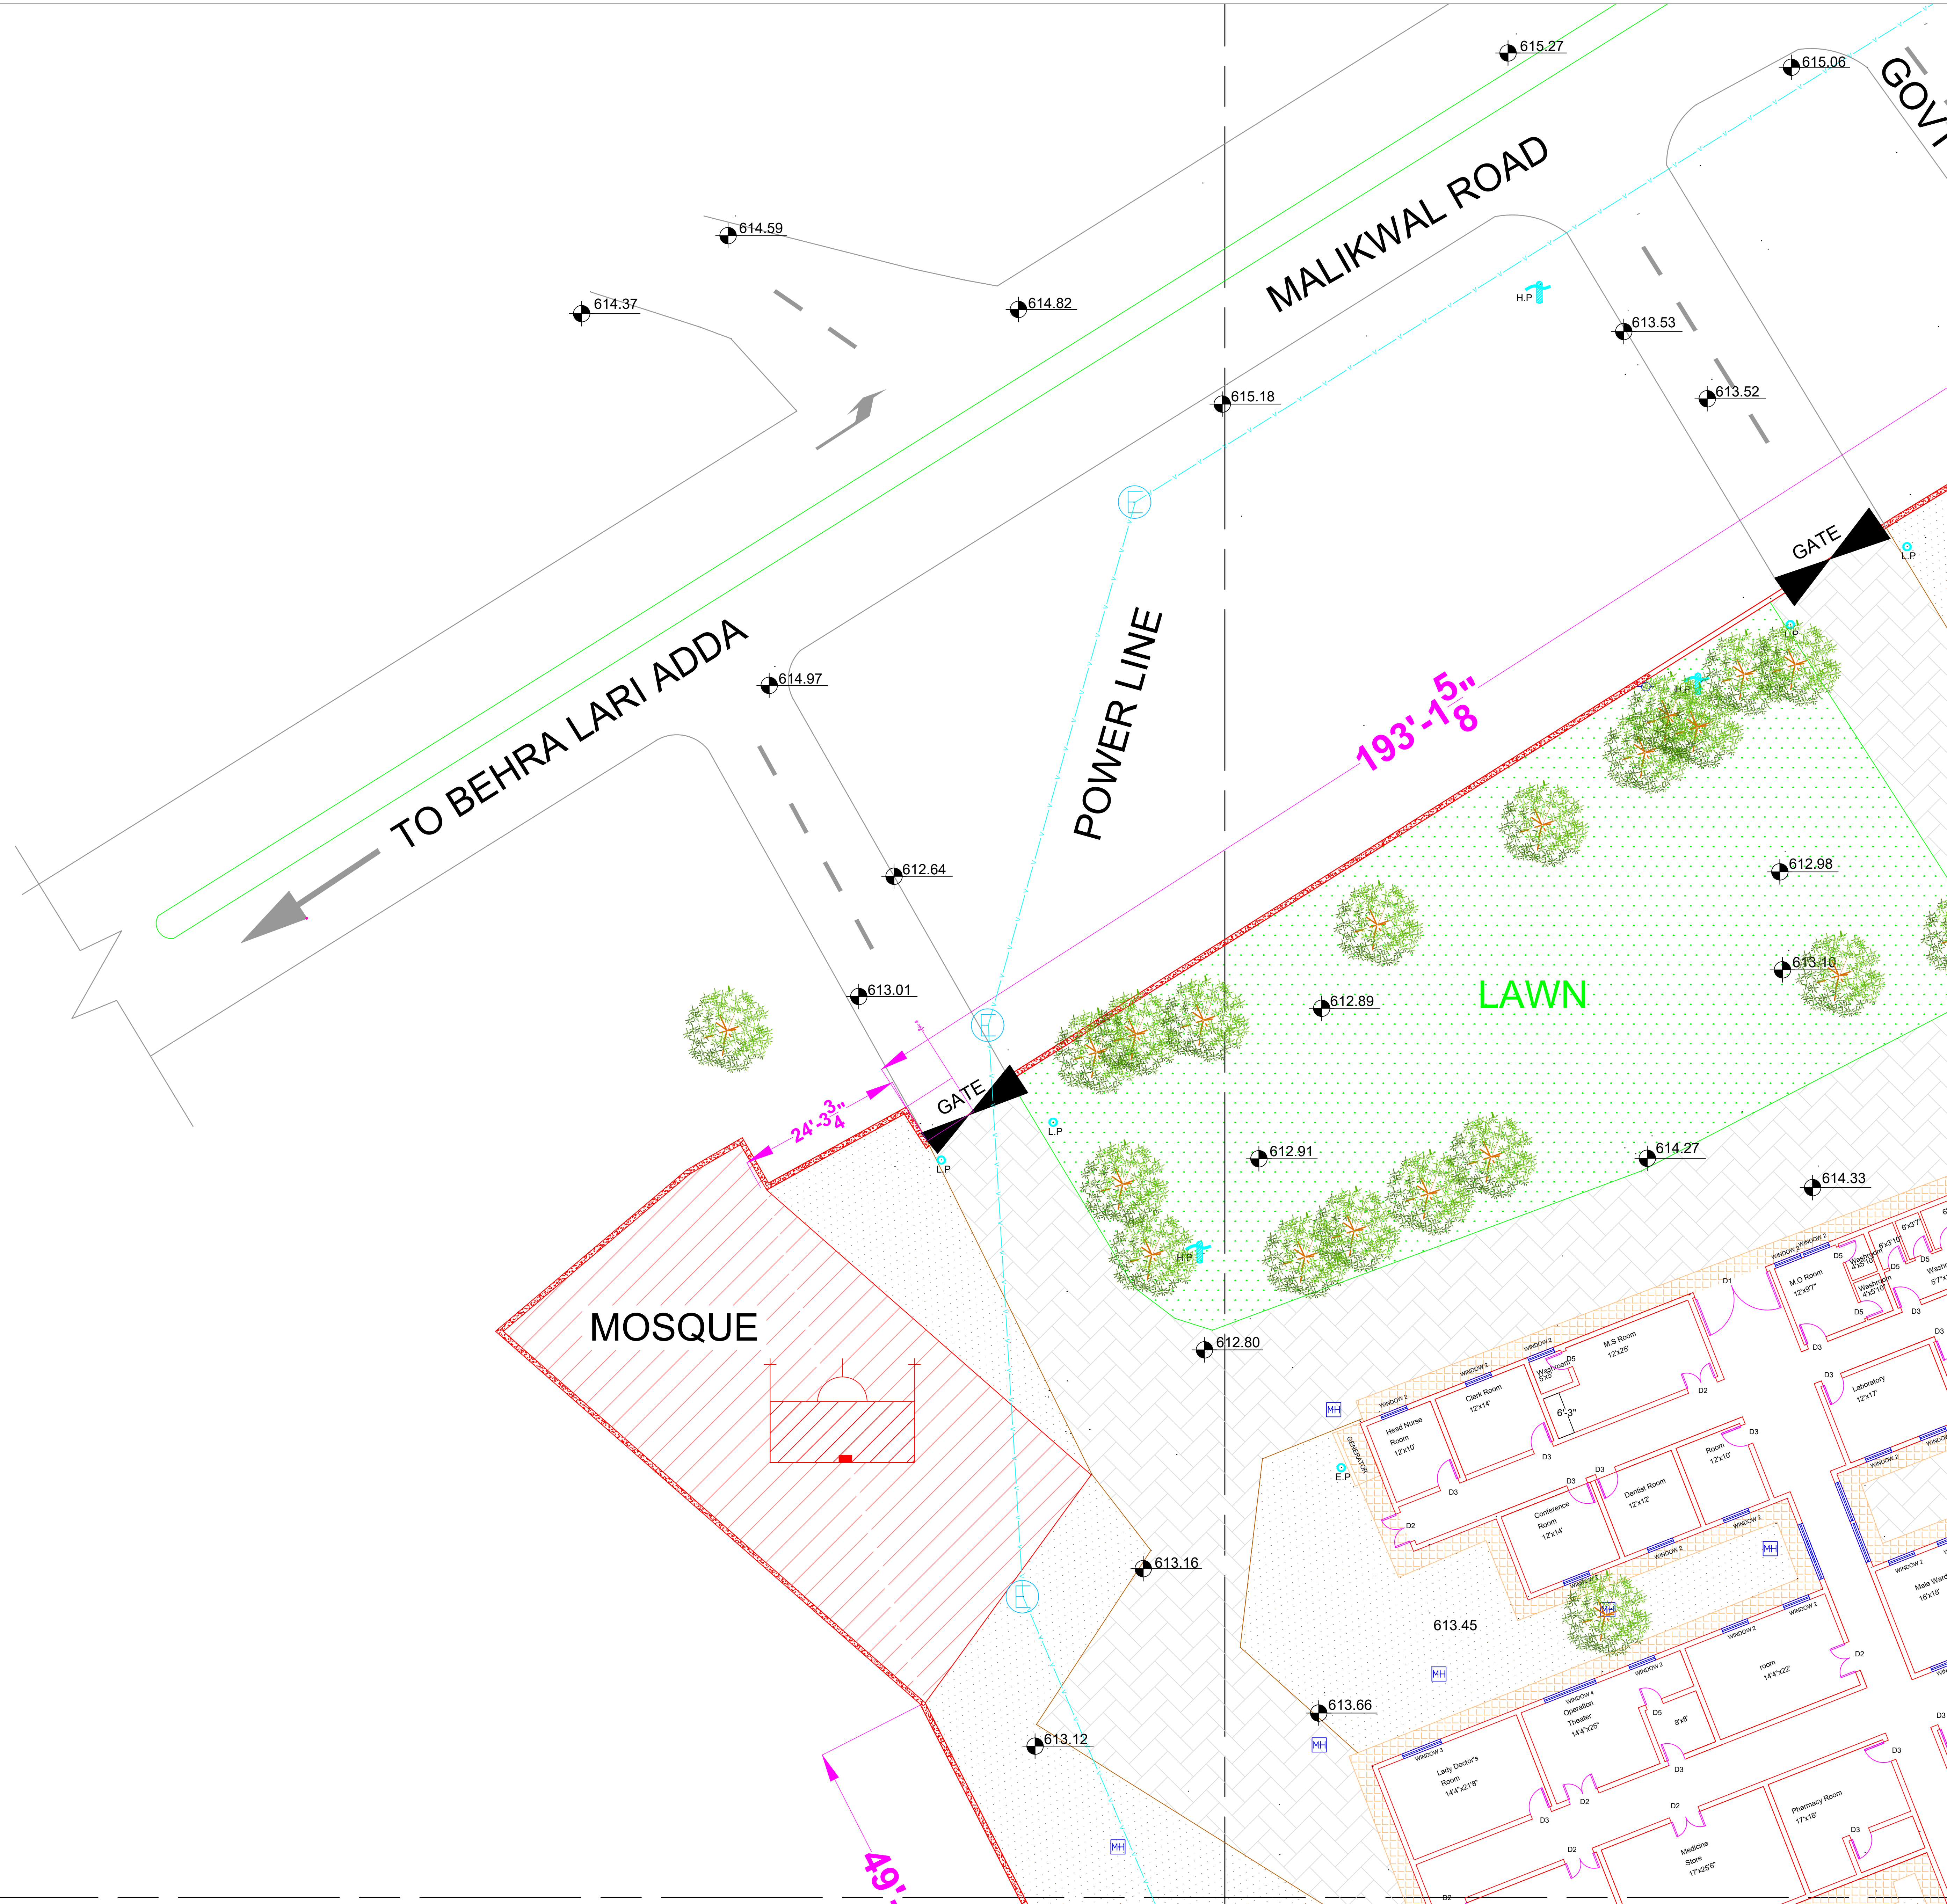

**Legends:**

Residential Area	
Road	
Wall	
Power Line	
OHT	
Tree	
ManHole	
Tube Well	
Light Pole	
Lawns	
Earthen Areas	
Asphalts Roads	
Tough Pavers	
P.C.C./Plinth Protection	
Boundary Wall	
Tap	
Hand Pump	
BRICK Pavers	
Air Conditioner	
Tube Light	
Fan	
Roof Light	
Bulb	

AREA	
AREA WITHIN BOUNDARY WALL	122241.3 Sft
AREA OF CLINICAL BLOCK	30403.64 Sft
PLINTH AREA OF BLOCK	23313.64 Sft

OPENING SCHEDULE OF DOORS AND WINDOWS					
DOORS	WIDTH	HEIGHT	WINDOWS	WIDTH	HEIGHT
D1	8'-0"	7'-0"	W1	3'-0"	5'-0"
D2	4'-6"	7'-0"	W2	4'-0"	4'-0"
D3	3'-0"	7'-0"	W3		
D4	3'-6"	7'-0"	W4		
D5	2'-6"	7'-0"	W5		
D6			W6		
D7			W7		
D8			V1		
D9			V2		

Client:

GOVERNMENT OF THE PUNJAB  
PRIMARY & SECONDARY  
HEALTHCARE DEPARTMENT

Project:

CAD MAPPING OF TEHSIL  
HEAD QUARTER HOSPITALS,  
PUNJAB

Consultant:

SKAFS CONSULTANT (Pvt.) Limited  
ENGINEERING AND ENVIRONMENT CONSULTANT

Drawing Title:

THQ MAILSI  
HOSPITAL MASTER PLAN  
PART 1

Authorized By: SKAFS	Reviewed By: Co-Team Leader	Scale:
Prepared By: CAD TEAMS	Date: FEB, 2017	Sheet:
Drawing No.		SKAFS/BHERA /04



# MASTER PLAN OF THQ HOSPITAL BHERA

## PART 2



**Legends:**

Residential Area	
Road	
Wall	
Power Line	
OHT	
Tree	
ManHole	
Tube Well	
Light Pole	
Lawns	
Earthen Areas	
Asphalts Roads	
Tough Pavers	
P.C.C./Plinth Protection	
Boundary Wall	
Tap	
Hand Pump	
BRICK Pavers	
Air Conditioner	
Tube Light	
Fan	
Roof Light	
Bulb	

AREA	
AREA WITHIN BOUNDARY WALL	122241.3 Sft
AREA OF CLINICAL BLOCK	30403.64 Sft
PLINTH AREA OF BLOCK	23313.64 Sft

OPENING SCHEDULE OF DOORS AND WINDOWS					
DOORS	WIDTH	HEIGHT	WINDOWS	WIDTH	HEIGHT
D1	8'-0"	7'-0"	W1	3'-0"	5'-0"
D2	4'-6"	7'-0"	W2	4'-0"	4'-0"
D3	3'-0"	7'-0"	W3		
D4	3'-6"	7'-0"	W4		
D5	2'-6"	7'-0"	W5		
D6			W6		
D7			W7		
D8			V1		
D9			V2		

Client:



GOVERNMENT OF THE PUNJAB  
PRIMARY & SECONDARY  
HEALTHCARE DEPARTMENT

Project:

CAD MAPPING OF TEHSIL  
HEAD QUARTER HOSPITALS,  
PUNJAB

Consultant:



SKAFS CONSULTANT (Pvt.) Limited  
ENGINEERING AND ENVIRONMENT CONSULTANT

Drawing Title:


THQ MAILSI  
HOSPITAL MASTER PLAN  
PART 2

Authorized By: SKAFS	Reviewed By Co-Team Leader	Scale:
Prepared By: CAD TEAMS	Date: FEB, 2017	Sheet:
Drawing No.		SKAFS/BHERA /05



# MASTER PLAN OF THQ HOSPITAL BHERA

## PART 3

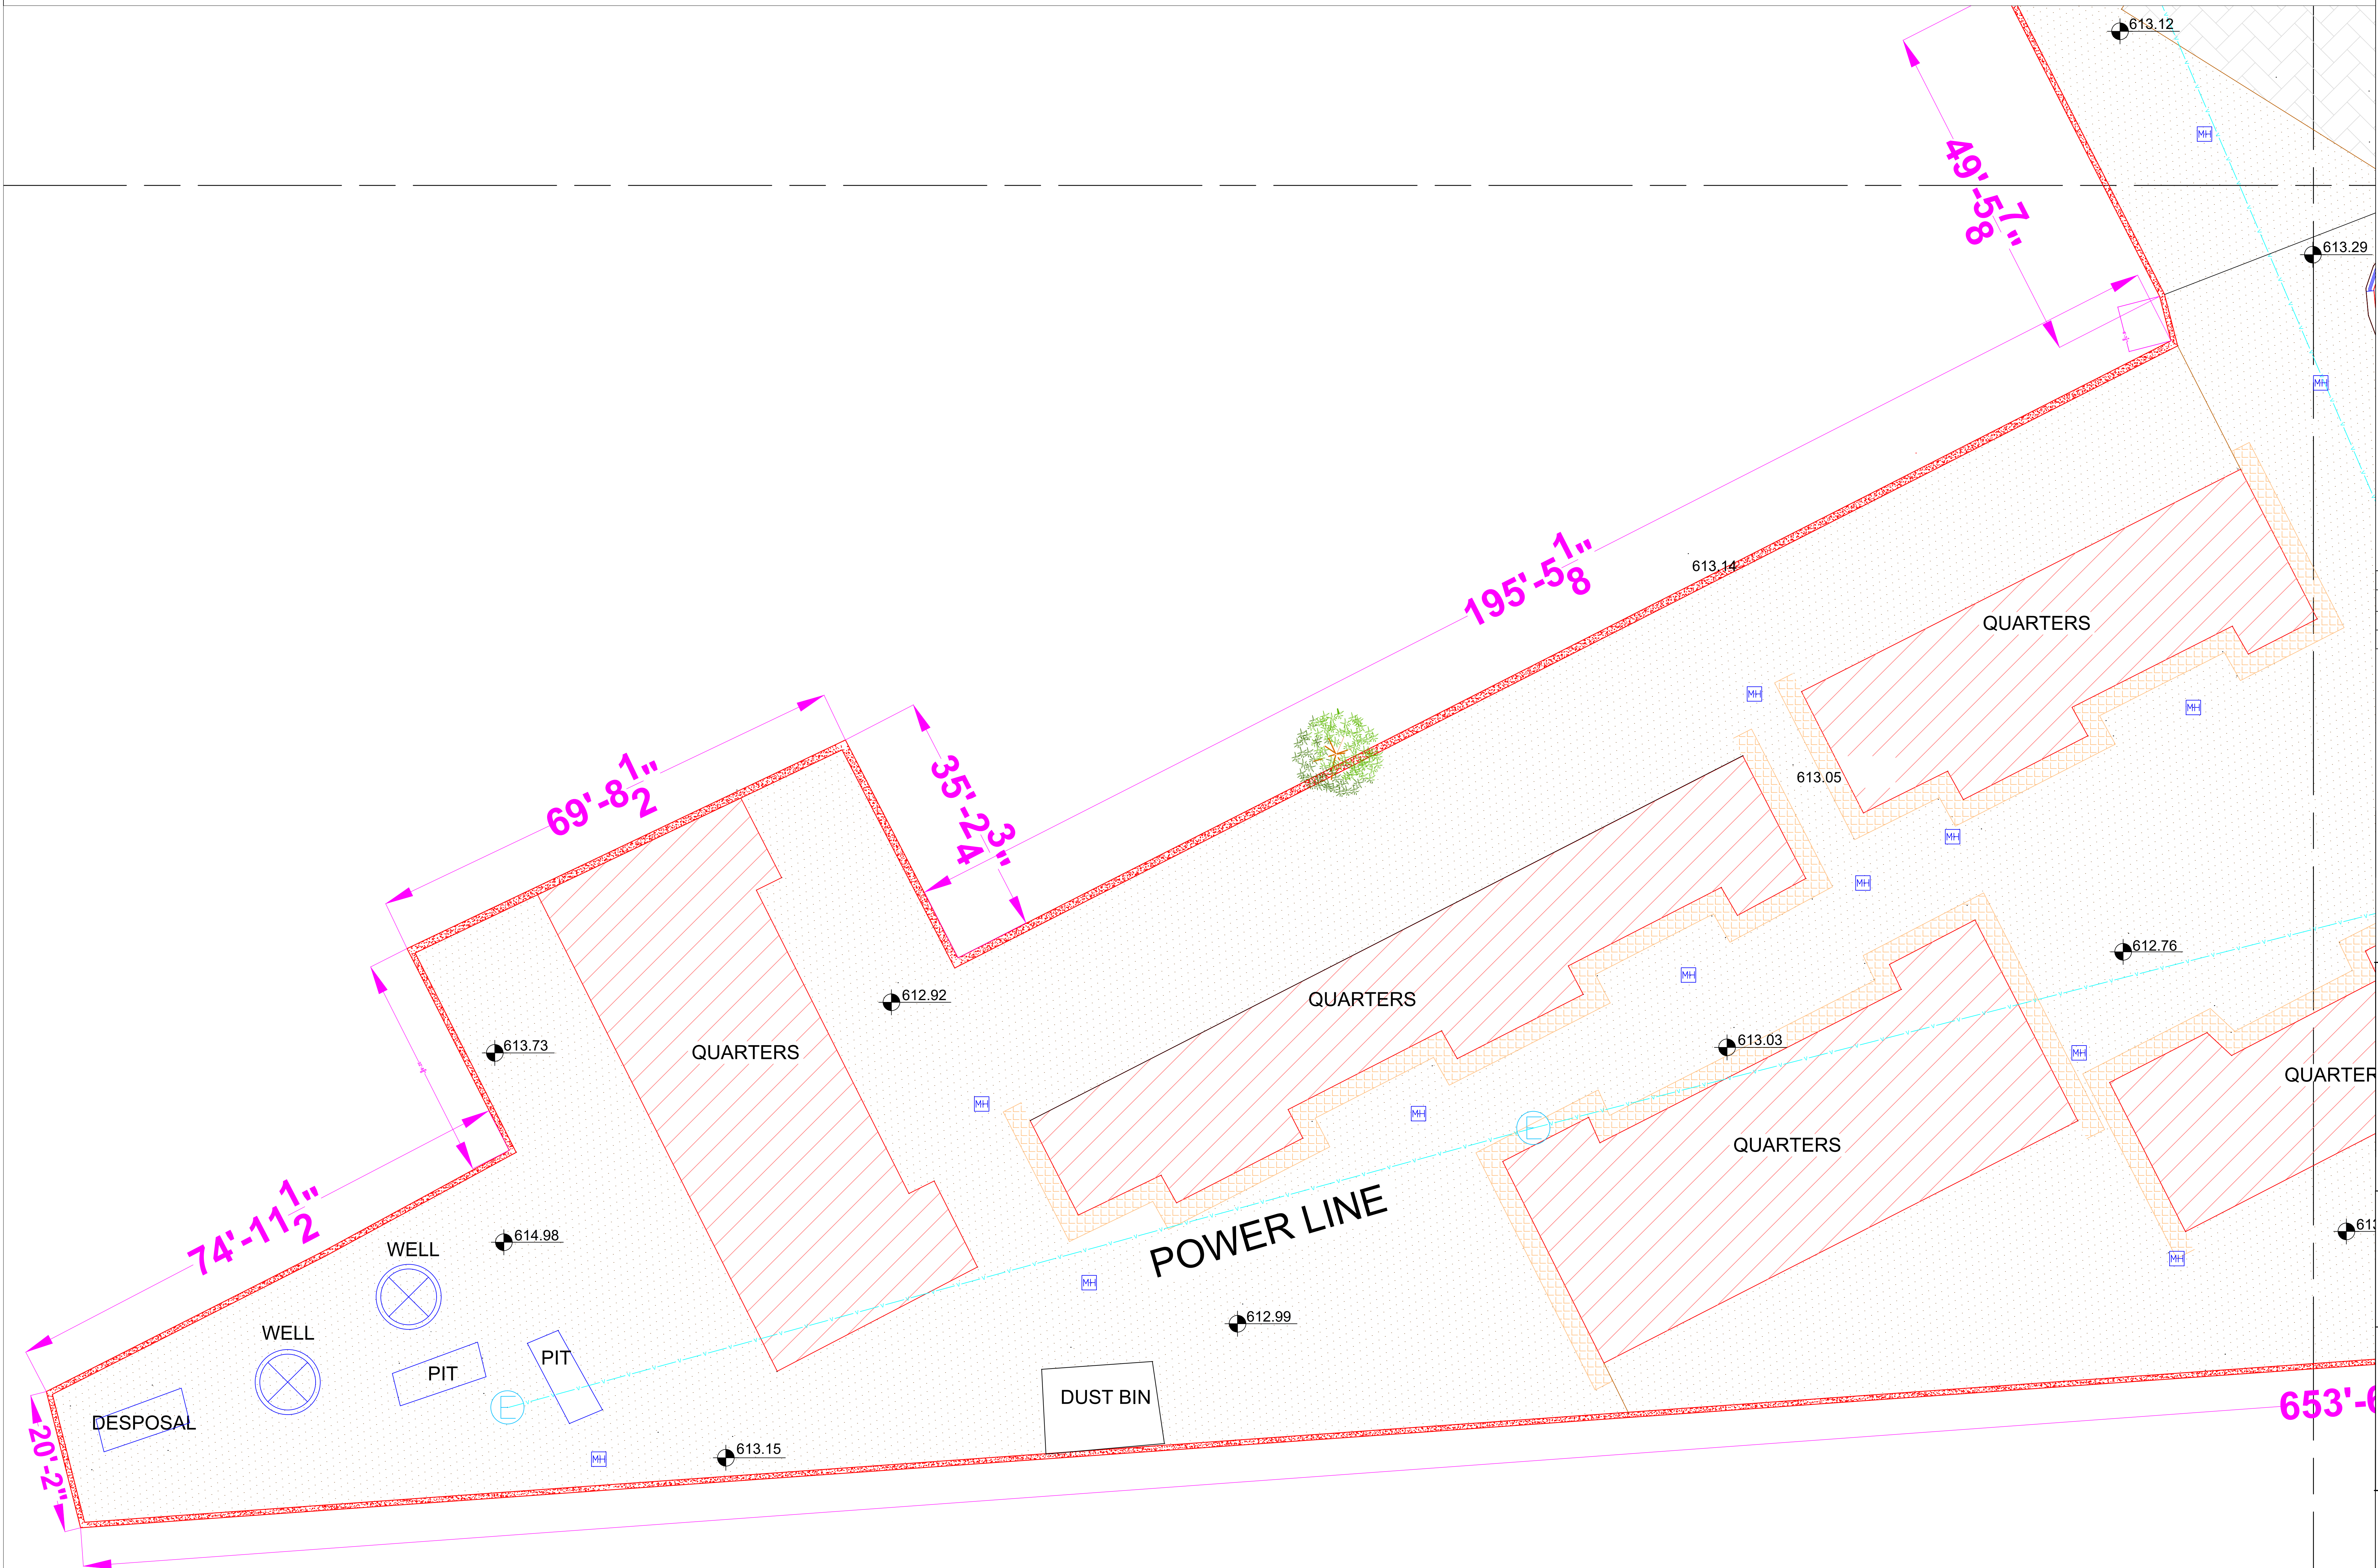

**Legends:**

Residential Area	
Road	
Wall	
Power Line	
OHT	
Tree	
ManHole	
Tube Well	
Light Pole	
Lawns	
Earthen Areas	
Asphalts Roads	
Tough Pavers	
P.C.C./Plinth Protection	
Boundary Wall	
Tap	
Hand Pump	
BRICK Pavers	
Air Conditioner	
Tube Light	
Fan	
Roof Light	
Bulb	

AREA	
AREA WITHIN BOUNDARY WALL	122241.3 Sft
AREA OF CLINICAL BLOCK	30403.64 Sft
PLINTH AREA OF BLOCK	23313.64 Sft

OPENING SCHEDULE OF DOORS AND WINDOWS					
DOORS	WIDTH	HEIGHT	WINDOWS	WIDTH	HEIGHT
D1	8'-0"	7'-0"	W1	3'-0"	5'-0"
D2	4'-6"	7'-0"	W2	4'-0"	4'-0"
D3	3'-0"	7'-0"	W3		
D4	3'-6"	7'-0"	W4		
D5	2'-6"	7'-0"	W5		
D6			W6		
D7			W7		
D8			V1		
D9			V2		

Client:

GOVERNMENT OF THE PUNJAB  
PRIMARY & SECONDARY  
HEALTHCARE DEPARTMENT

Project:

CAD MAPPING OF TEHSIL  
HEAD QUARTER HOSPITALS,  
PUNJAB

Consultant:

SKAFS CONSULTANT (Pvt.) Limited  
ENGINEERING AND ENVIRONMENT CONSULTANT

Drawing Title:

THQ MAILSI  
HOSPITAL MASTER PLAN  
PART 3


Authorized By: SKAFS	Reviewed By Co-Team Leader	Scale:
Prepared By: CAD TEAMS	Date: FEB, 2017	
Drawing No.		

SKAFS/BHERA /06



# MASTER PLAN OF THQ HOSPITAL BHERA

## PART 4

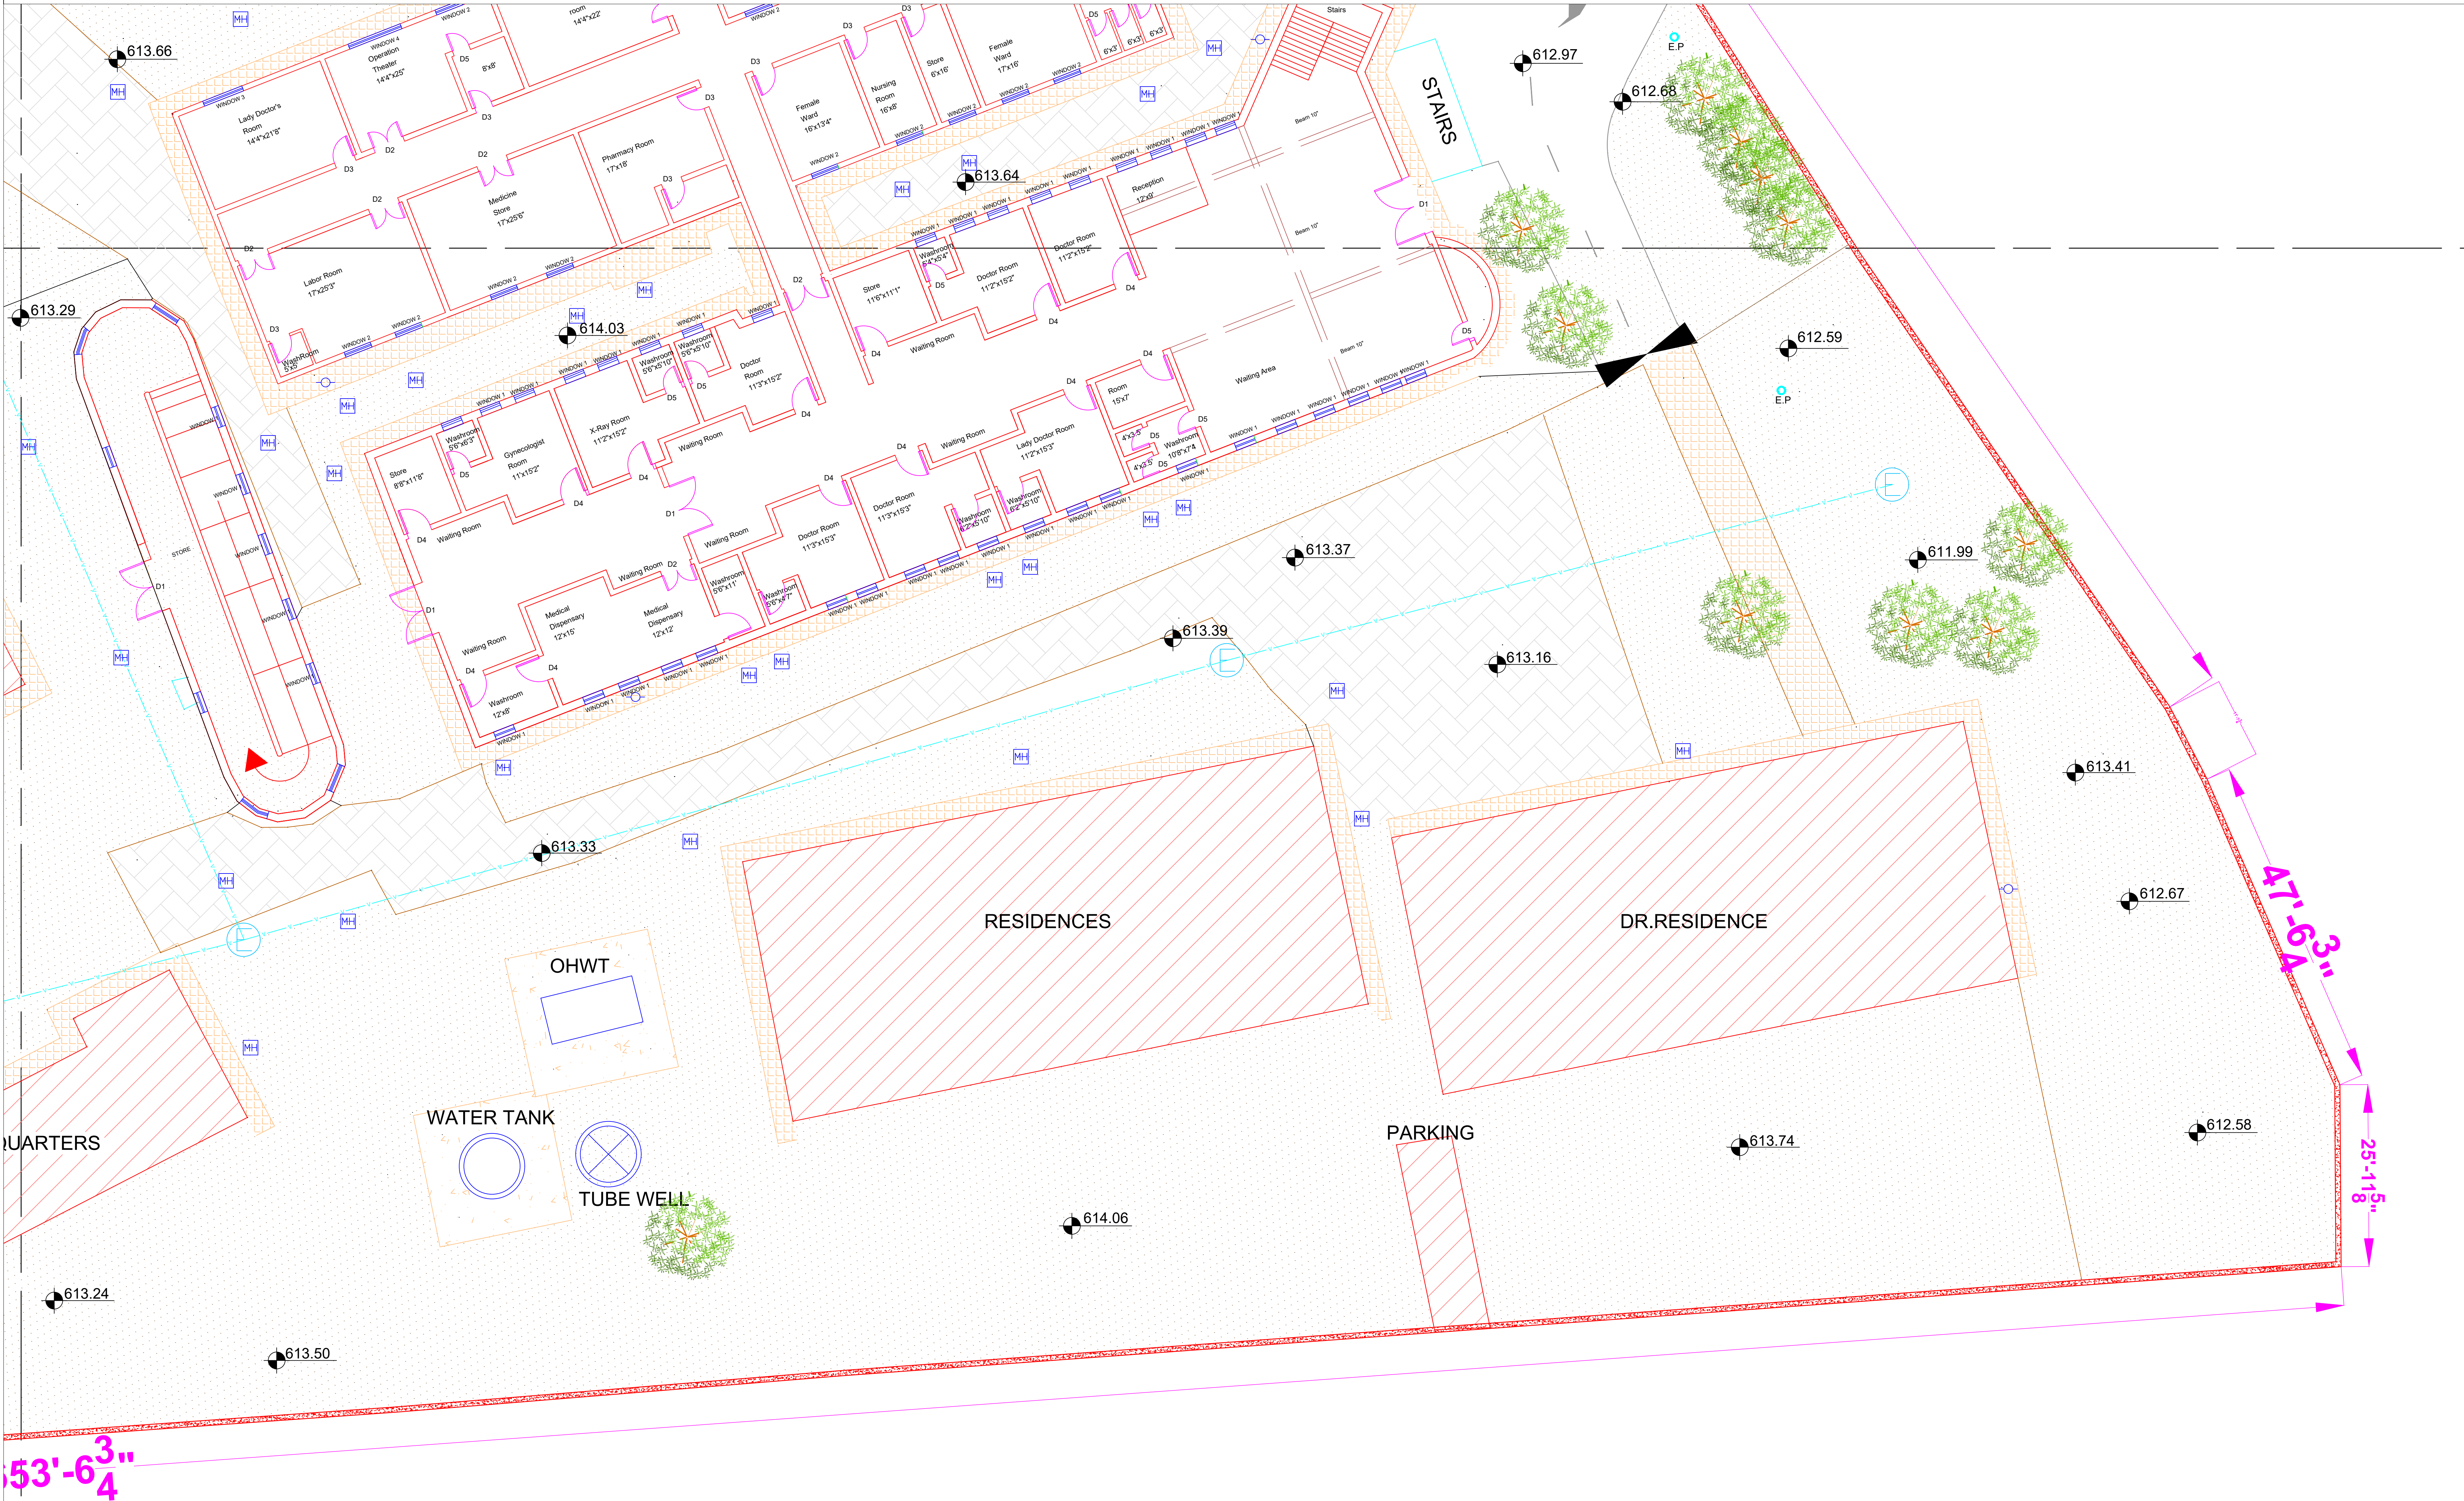

**Legends:**

Residential Area	
Road	
Wall	
Power Line	
OHT	
Tree	
ManHole	
Tube Well	
Light Pole	
Lawns	
Earthen Areas	
Asphalts Roads	
Tough Pavers	
P.C.C./Plinth Protection	
Boundary Wall	
Tap	
Hand Pump	
BRICK Pavers	
Air Conditioner	
Tube Light	
Fan	
Roof Light	
Bulb	

AREA	
AREA WITHIN BOUNDARY WALL	122241.3 Sft
AREA OF CLINICAL BLOCK	30403.64 Sft
PLINTH AREA OF BLOCK	23313.64 Sft

OPENING SCHEDULE OF DOORS AND WINDOWS					
DOORS	WIDTH	HEIGHT	WINDOWS	WIDTH	HEIGHT
D1	8'-0"	7'-0"	W1	3'-0"	5'-0"
D2	4'-6"	7'-0"	W2	4'-0"	4'-0"
D3	3'-0"	7'-0"	W3		
D4	3'-6"	7'-0"	W4		
D5	2'-6"	7'-0"	W5		
D6			W6		
D7			W7		
D8			V1		
D9			V2		

Client:

GOVERNMENT OF THE PUNJAB  
PRIMARY & SECONDARY  
HEALTHCARE DEPARTMENT

Project:

CAD MAPPING OF TEHSIL  
HEAD QUARTER HOSPITALS,  
PUNJAB

Consultant:

SKAFS CONSULTANT (Pvt.) Limited  
ENGINEERING AND ENVIRONMENT CONSULTANT

Drawing Title:

THQ MAILSI  
HOSPITAL MASTER PLAN  
PART 4

Authorized By: SKAFS	Reviewed By Co-Team Leader	Scale:
-------------------------	-------------------------------	--------

Prepared By: CAD TEAMS	Date: FEB, 2017	
---------------------------	--------------------	--



# CLINICAL BLOCK OF THQ HOSPITAL BHERA

## GROUND FLOOR

PART 1

PART 2

PART 3

PART 4



**Legends:**

Residential Area	
Road	
Wall	
Power Line	
OHT	
Tree	
ManHole	
Tube Well	
Light Pole	
Lawns	
Earthen Areas	
Asphalts Roads	
Tough Pavers	
P.C.C./Plinth Protection	
Boundary Wall	
Tap	
Hand Pump	
BRICK Pavers	
Air Conditioner	
Tube Light	
Fan	
Roof Light	
Bulb	

AREA	
AREA WITHIN BOUNDARY WALL	122241.3 Sft
AREA OF CLINICAL BLOCK	30403.64 Sft
PLINTH AREA OF BLOCK	23313.64 Sft

OPENING SCHEDULE OF DOORS AND WINDOWS					
DOORS	WIDTH	HEIGHT	WINDOWS	WIDTH	HEIGHT
D1	8'-0"	7'-0"	W1	3'-0"	5'-0"
D2	4'-6"	7'-0"	W2	4'-0"	4'-0"
D3	3'-0"	7'-0"	W3		
D4	3'-6"	7'-0"	W4		
D5	2'-6"	7'-0"	W5		
D6			W6		
D7			W7		
D8			V1		
D9			V2		

Client:

GOVERNMENT OF THE PUNJAB  
PRIMARY & SECONDARY  
HEALTHCARE DEPARTMENT

Project:

CAD MAPPING OF TEHSIL  
HEAD QUARTER HOSPITALS,  
PUNJAB

Consultant:

SKAFS CONSULTANT (Pvt.) Limited  
ENGINEERING AND ENVIRONMENT CONSULTANT

Drawing Title:

THQ MAILSI  
HOSPITAL MAIN BUILDING  
CLINICAL BLOCK PLAN

Authorized By: SKAFS	Reviewed By Co-Team Leader	Scale: 1:300
Prepared By: CAD TEAMS	Date: FEB, 2017	
Drawing No.		

SKAFS/BHERA /08



# CLINICAL BLOCK OF THQ HOSPITAL BHERA

## GROUND FLOOR (PART 1)



**Legends:**

Residential Area	
Road	
Wall	
Power Line	
OHT	
Tree	
ManHole	
Tube Well	
Light Pole	
Lawns	
Earthen Areas	
Asphalts Roads	
Tough Pavers	
P.C.C./Plinth Protection	
Boundary Wall	
Tap	
Hand Pump	
BRICK Pavers	
Air Conditioner	
Tube Light	
Fan	
Roof Light	
Bulb	

AREA	
AREA WITHIN BOUNDARY WALL	122241.3 Sft
AREA OF CLINICAL BLOCK	30403.64 Sft
PLINTH AREA OF BLOCK	23313.64 Sft

OPENING SCHEDULE OF DOORS AND WINDOWS					
DOORS	WIDTH	HEIGHT	WINDOWS	WIDTH	HEIGHT
D1	8'-0"	7'-0"	W1	3'-0"	5'-0"
D2	4'-6"	7'-0"	W2	4'-0"	4'-0"
D3	3'-0"	7'-0"	W3		
D4	3'-6"	7'-0"	W4		
D5	2'-6"	7'-0"	W5		
D6			W6		
D7			W7		
D8			V1		
D9			V2		

Client:



**GOVERNMENT OF THE PUNJAB**  
**PRIMARY & SECONDARY**  
**HEALTHCARE DEPARTMENT**

Project:

**CAD MAPPING OF TEHSIL**  
**HEAD QUARTER HOSPITALS,**  
**PUNJAB**

Consultant:



**SKAFS CONSULTANT (Pvt.) Limited**  
ENGINEERING AND ENVIRONMENT CONSULTANT

Drawing Title:

**THQ MAILSI**  
**HOSPITAL CLINICAL BLOCK**  
**PART 1**

Authorized By: SKAFS	Reviewed By Co-Team Leader	Scale:
Prepared By: CAD TEAMS	Date: FEB, 2017	
Drawing No. <b>SKAFS/BHERA /09</b>		



# CLINICAL BLOCK OF THQ HOSPITAL BHERA

## GROUND FLOOR (PART 2)



**Legends:**

Residential Area	
Road	
Wall	
Power Line	
OHT	
Tree	
ManHole	
Tube Well	
Light Pole	
Lawns	
Earthen Areas	
Asphalts Roads	
Tough Pavers	
P.C.C./Plinth Protection	
Boundary Wall	
Tap	
Hand Pump	
BRICK Pavers	
Air Conditioner	
Tube Light	
Fan	
Roof Light	
Bulb	

AREA	
AREA WITHIN BOUNDARY WALL	122241.3 Sft
AREA OF CLINICAL BLOCK	30403.64 Sft
PLINTH AREA OF BLOCK	23313.64 Sft

OPENING SCHEDULE OF DOORS AND WINDOWS					
DOORS	WIDTH	HEIGHT	WINDOWS	WIDTH	HEIGHT
D1	8'-0"	7'-0"	W1	3'-0"	5'-0"
D2	4'-6"	7'-0"	W2	4'-0"	4'-0"
D3	3'-0"	7'-0"	W3		
D4	3'-6"	7'-0"	W4		
D5	2'-6"	7'-0"	W5		
D6			W6		
D7			W7		
D8			V1		
D9			V2		

Client:

GOVERNMENT OF THE PUNJAB  
PRIMARY & SECONDARY  
HEALTHCARE DEPARTMENT

Project:

**CAD MAPPING OF TEHSIL  
HEAD QUARTER HOSPITALS,  
PUNJAB**

Consultant:

**SKAFS CONSULTANT (Pvt.) Limited**  
ENGINEERING AND ENVIRONMENT CONSULTANT

Drawing Title:

**THQ MAILSI  
HOSPITAL CLINICAL BLOCK  
PART 2**

Authorized By: SKAFS	Reviewed By Co-Team Leader	Scale:
Prepared By: CAD TEAMS	Date: FEB, 2017	
Drawing No.		<b>SKAFS/BHERA /10</b>



# CLINICAL BLOCK OF THQ HOSPITAL BHERA

## GROUND FLOOR (PART 3)



**Legends:**

Residential Area	
Road	
Wall	
Power Line	
OHT	
Tree	
ManHole	
Tube Well	
Light Pole	
Lawns	
Earthen Areas	
Asphalts Roads	
Tough Pavers	
P.C.C./Plinth Protection	
Boundary Wall	
Tap	
Hand Pump	
BRICK Pavers	
Air Conditioner	
Tube Light	
Fan	
Roof Light	
Bulb	

AREA	
AREA WITHIN BOUNDARY WALL	122241.3 Sft
AREA OF CLINICAL BLOCK	30403.64 Sft
PLINTH AREA OF BLOCK	23313.64 Sft

OPENING SCHEDULE OF DOORS AND WINDOWS					
DOORS	WIDTH	HEIGHT	WINDOWS	WIDTH	HEIGHT
D1	8'-0"	7'-0"	W1	3'-0"	5'-0"
D2	4'-6"	7'-0"	W2	4'-0"	4'-0"
D3	3'-0"	7'-0"	W3		
D4	3'-6"	7'-0"	W4		
D5	2'-6"	7'-0"	W5		
D6			W6		
D7			W7		
D8			V1		
D9			V2		

Client:

GOVERNMENT OF THE PUNJAB  
PRIMARY & SECONDARY  
HEALTHCARE DEPARTMENT

Project:

CAD MAPPING OF TEHSIL  
HEAD QUARTER HOSPITALS,  
PUNJAB

Consultant:

SKAFS CONSULTANT (Pvt.) Limited  
ENGINEERING AND ENVIRONMENT CONSULTANT

Drawing Title:

THQ MAILSI  
HOSPITAL CLINICAL BLOCK  
PART 3

Authorized By: SKAFS	Reviewed By Co-Team Leader	Scale:
Prepared By: CAD TEAMS	Date: FEB, 2017	
Drawing No.		

SKAFS/BHERA /11



# CLINICAL BLOCK OF THQ HOSPITAL BHERA

## GROUND FLOOR (PART 4)



**Legends:**

Residential Area	
Road	
Wall	
Power Line	
OHT	
Tree	
ManHole	
Tube Well	
Light Pole	
Lawns	
Earthen Areas	
Asphalts Roads	
Tough Pavers	
P.C.C./Plinth Protection	
Boundary Wall	
Tap	
Hand Pump	
BRICK Pavers	
Air Conditioner	
Tube Light	
Fan	
Roof Light	
Bulb	

AREA	
AREA WITHIN BOUNDARY WALL	122241.3 Sft
AREA OF CLINICAL BLOCK	30403.64 Sft
PLINTH AREA OF BLOCK	23313.64 Sft

OPENING SCHEDULE OF DOORS AND WINDOWS					
DOORS	WIDTH	HEIGHT	WINDOWS	WIDTH	HEIGHT
D1	8'-0"	7'-0"	W1	3'-0"	5'-0"
D2	4'-6"	7'-0"	W2	4'-0"	4'-0"
D3	3'-0"	7'-0"	W3		
D4	3'-6"	7'-0"	W4		
D5	2'-6"	7'-0"	W5		
D6			W6		
D7			W7		
D8			V1		
D9			V2		

Client:



**GOVERNMENT OF THE PUNJAB**  
**PRIMARY & SECONDARY**  
**HEALTHCARE DEPARTMENT**

Project:

**CAD MAPPING OF TEHSIL  
HEAD QUARTER HOSPITALS,  
PUNJAB**

Consultant:



**SKAFS CONSULTANT (Pvt.) Limited**  
ENGINEERING AND ENVIRONMENT CONSULTANT

Drawing Title:

**THQ MAILSI  
HOSPITAL CLINICAL BLOCK  
PART 4**

Authorized By: SKAFS	Reviewed By Co-Team Leader	Scale:
Prepared By: CAD TEAMS	Date: FEB, 2017	
Drawing No. <b>SKAFS/BHERA /12</b>		



# CLINICAL BLOCK OF THQ HOSPITAL BHERA

## FIRST FLOOR (PART 1)



**Legends:**

Residential Area	
Road	
Wall	
Power Line	
OHT	
Tree	
ManHole	
Tube Well	
Light Pole	
Lawns	
Earthen Areas	
Asphalts Roads	
Tough Pavers	
P.C.C./Plinth Protection	
Boundary Wall	
Tap	
Hand Pump	
BRICK Pavers	
Air Conditioner	
Tube Light	
Fan	
Roof Light	
Bulb	

AREA	
AREA WITHIN BOUNDARY WALL	122241.3 Sft
AREA OF CLINICAL BLOCK	30403.64 Sft
PLINTH AREA OF BLOCK	23313.64 Sft

OPENING SCHEDULE OF DOORS AND WINDOWS					
DOORS	WIDTH	HEIGHT	WINDOWS	WIDTH	HEIGHT
D1	8'-0"	7'-0"	W1	3'-0"	5'-0"
D2	4'-6"	7'-0"	W2	4'-0"	4'-0"
D3	3'-0"	7'-0"	W3		
D4	3'-6"	7'-0"	W4		
D5	2'-6"	7'-0"	W5		
D6			W6		
D7			W7		
D8			V1		
D9			V2		

Client:



GOVERNMENT OF THE PUNJAB  
PRIMARY & SECONDARY  
HEALTHCARE DEPARTMENT

Project:

CAD MAPPING OF TEHSIL  
HEAD QUARTER HOSPITALS,  
PUNJAB

Consultant:



SKAFS CONSULTANT (Pvt.) Limited  
ENGINEERING AND ENVIRONMENT CONSULTANT

Drawing Title:

THQ MAILSI  
HOSPITAL CLINICAL BLOCK  
PART 4


Authorized By: SKAFS	Reviewed By Co-Team Leader	Scale:
-------------------------	-------------------------------	--------

Prepared By: CAD TEAMS	Date: FEB, 2017	
---------------------------	--------------------	--



# ELECTRICAL LAYOUT PLAN OF THQ HOSPITAL BHERA

## GROUND FLOOR

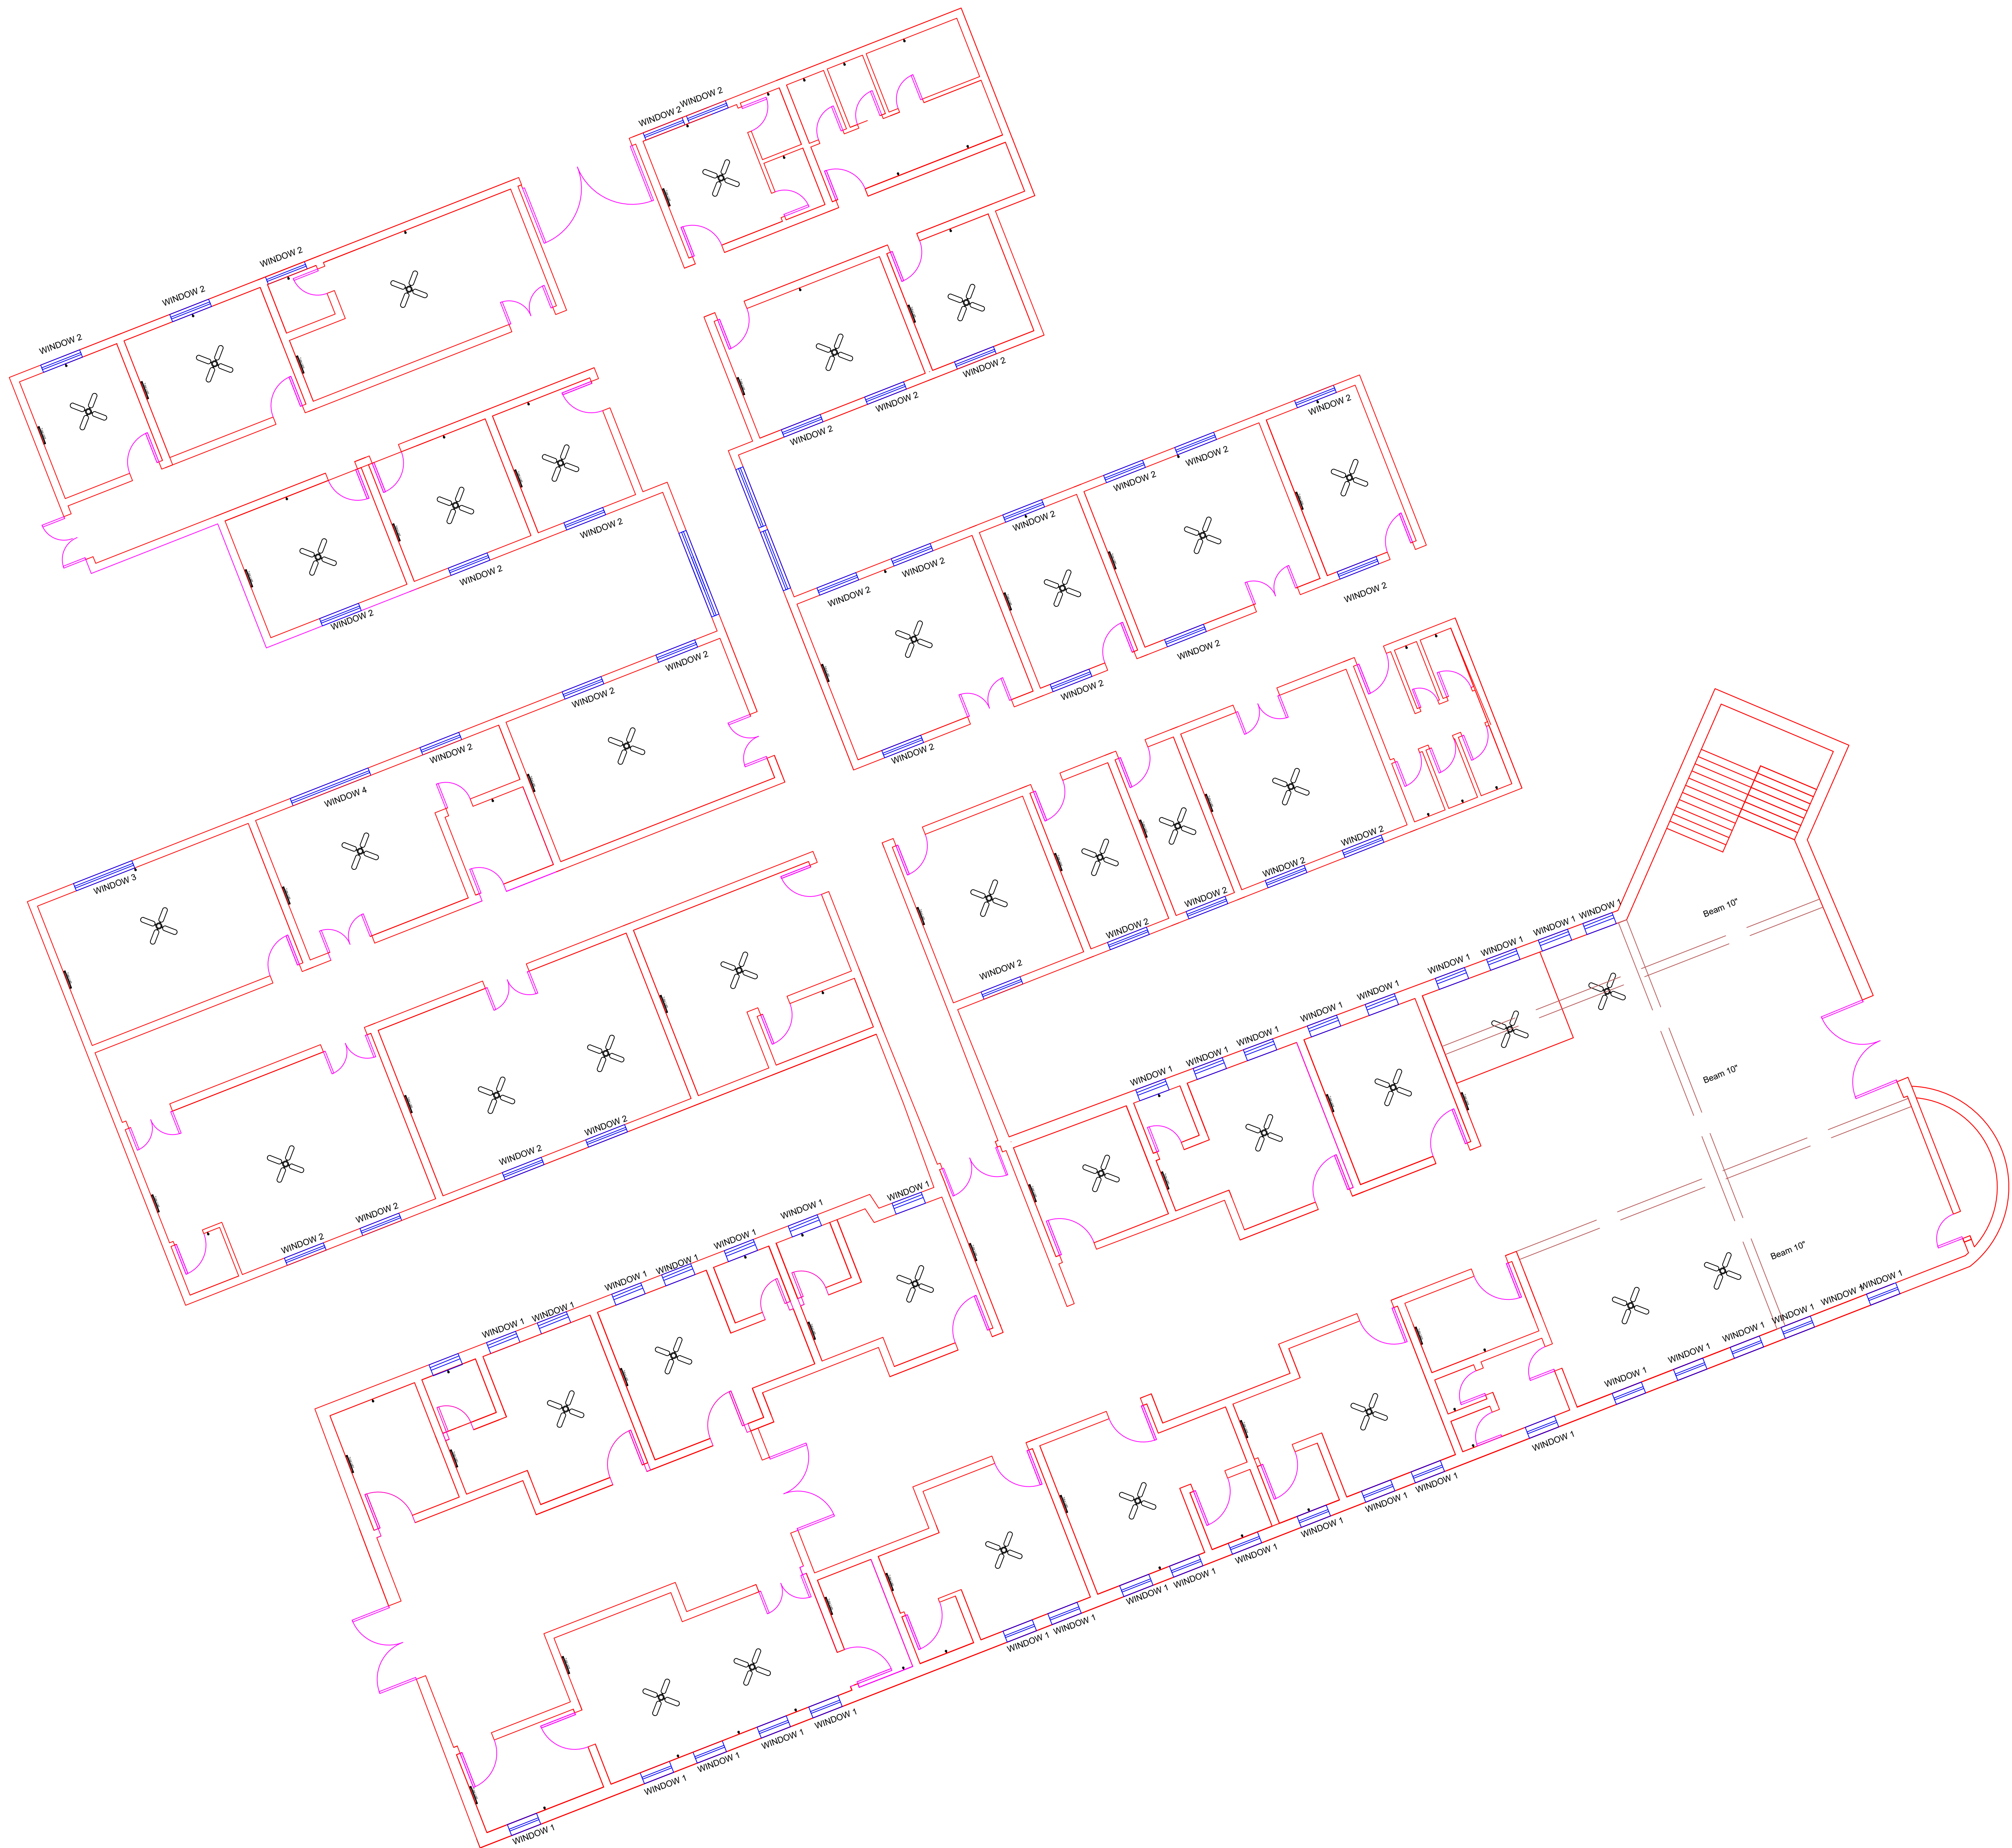

Legends:

Residential Area	
Road	
Wall	
Power Line	
OHT	
Tree	
ManHole	
Tube Well	
Light Pole	
Lawns	
Earthen Areas	
Asphalts Roads	
Tough Pavers	
P.C.C./Plinth Protection	
Boundary Wall	
Tap	
Hand Pump	
BRICK Pavers	
Air Conditioner	
Tube Light	
Fan	
Roof Light	
Bulb	

AREA	
AREA WITHIN BOUNDARY WALL	122241.3 Sft
AREA OF CLINICAL BLOCK	30403.64 Sft
PLINTH AREA OF BLOCK	23313.64 Sft

OPENING SCHEDULE OF DOORS AND WINDOWS					
DOORS	WIDTH	HEIGHT	WINDOWS	WIDTH	HEIGHT
D1	8'-0"	7'-0"	W1	3'-0"	5'-0"
D2	4'-6"	7'-0"	W2	4'-0"	4'-0"
D3	3'-0"	7'-0"	W3		
D4	3'-6"	7'-0"	W4		
D5	2'-6"	7'-0"	W5		
D6			W6		
D7			W7		
D8			V1		
D9			V2		

Client:



GOVERNMENT OF THE PUNJAB  
PRIMARY & SECONDARY  
HEALTHCARE DEPARTMENT

Project:

CAD MAPPING OF TEHSIL  
HEAD QUARTER HOSPITALS,  
PUNJAB

Consultant:



SKAFS CONSULTANT (Pvt.) Limited  
ENGINEERING AND ENVIRONMENT CONSULTANT

Drawing Title:


THQ MAILSI  
ELECTRICAL LAYOUT  
GROUND FLOOR

Authorized By: SKAFS	Reviewed By Co-Team Leader	Scale:
Prepared By: CAD TEAMS	Date: FEB, 2017	



# ELECTRICAL LAYOUT PLAN OF THQ HOSPITAL BHERA

## FIRST FLOOR

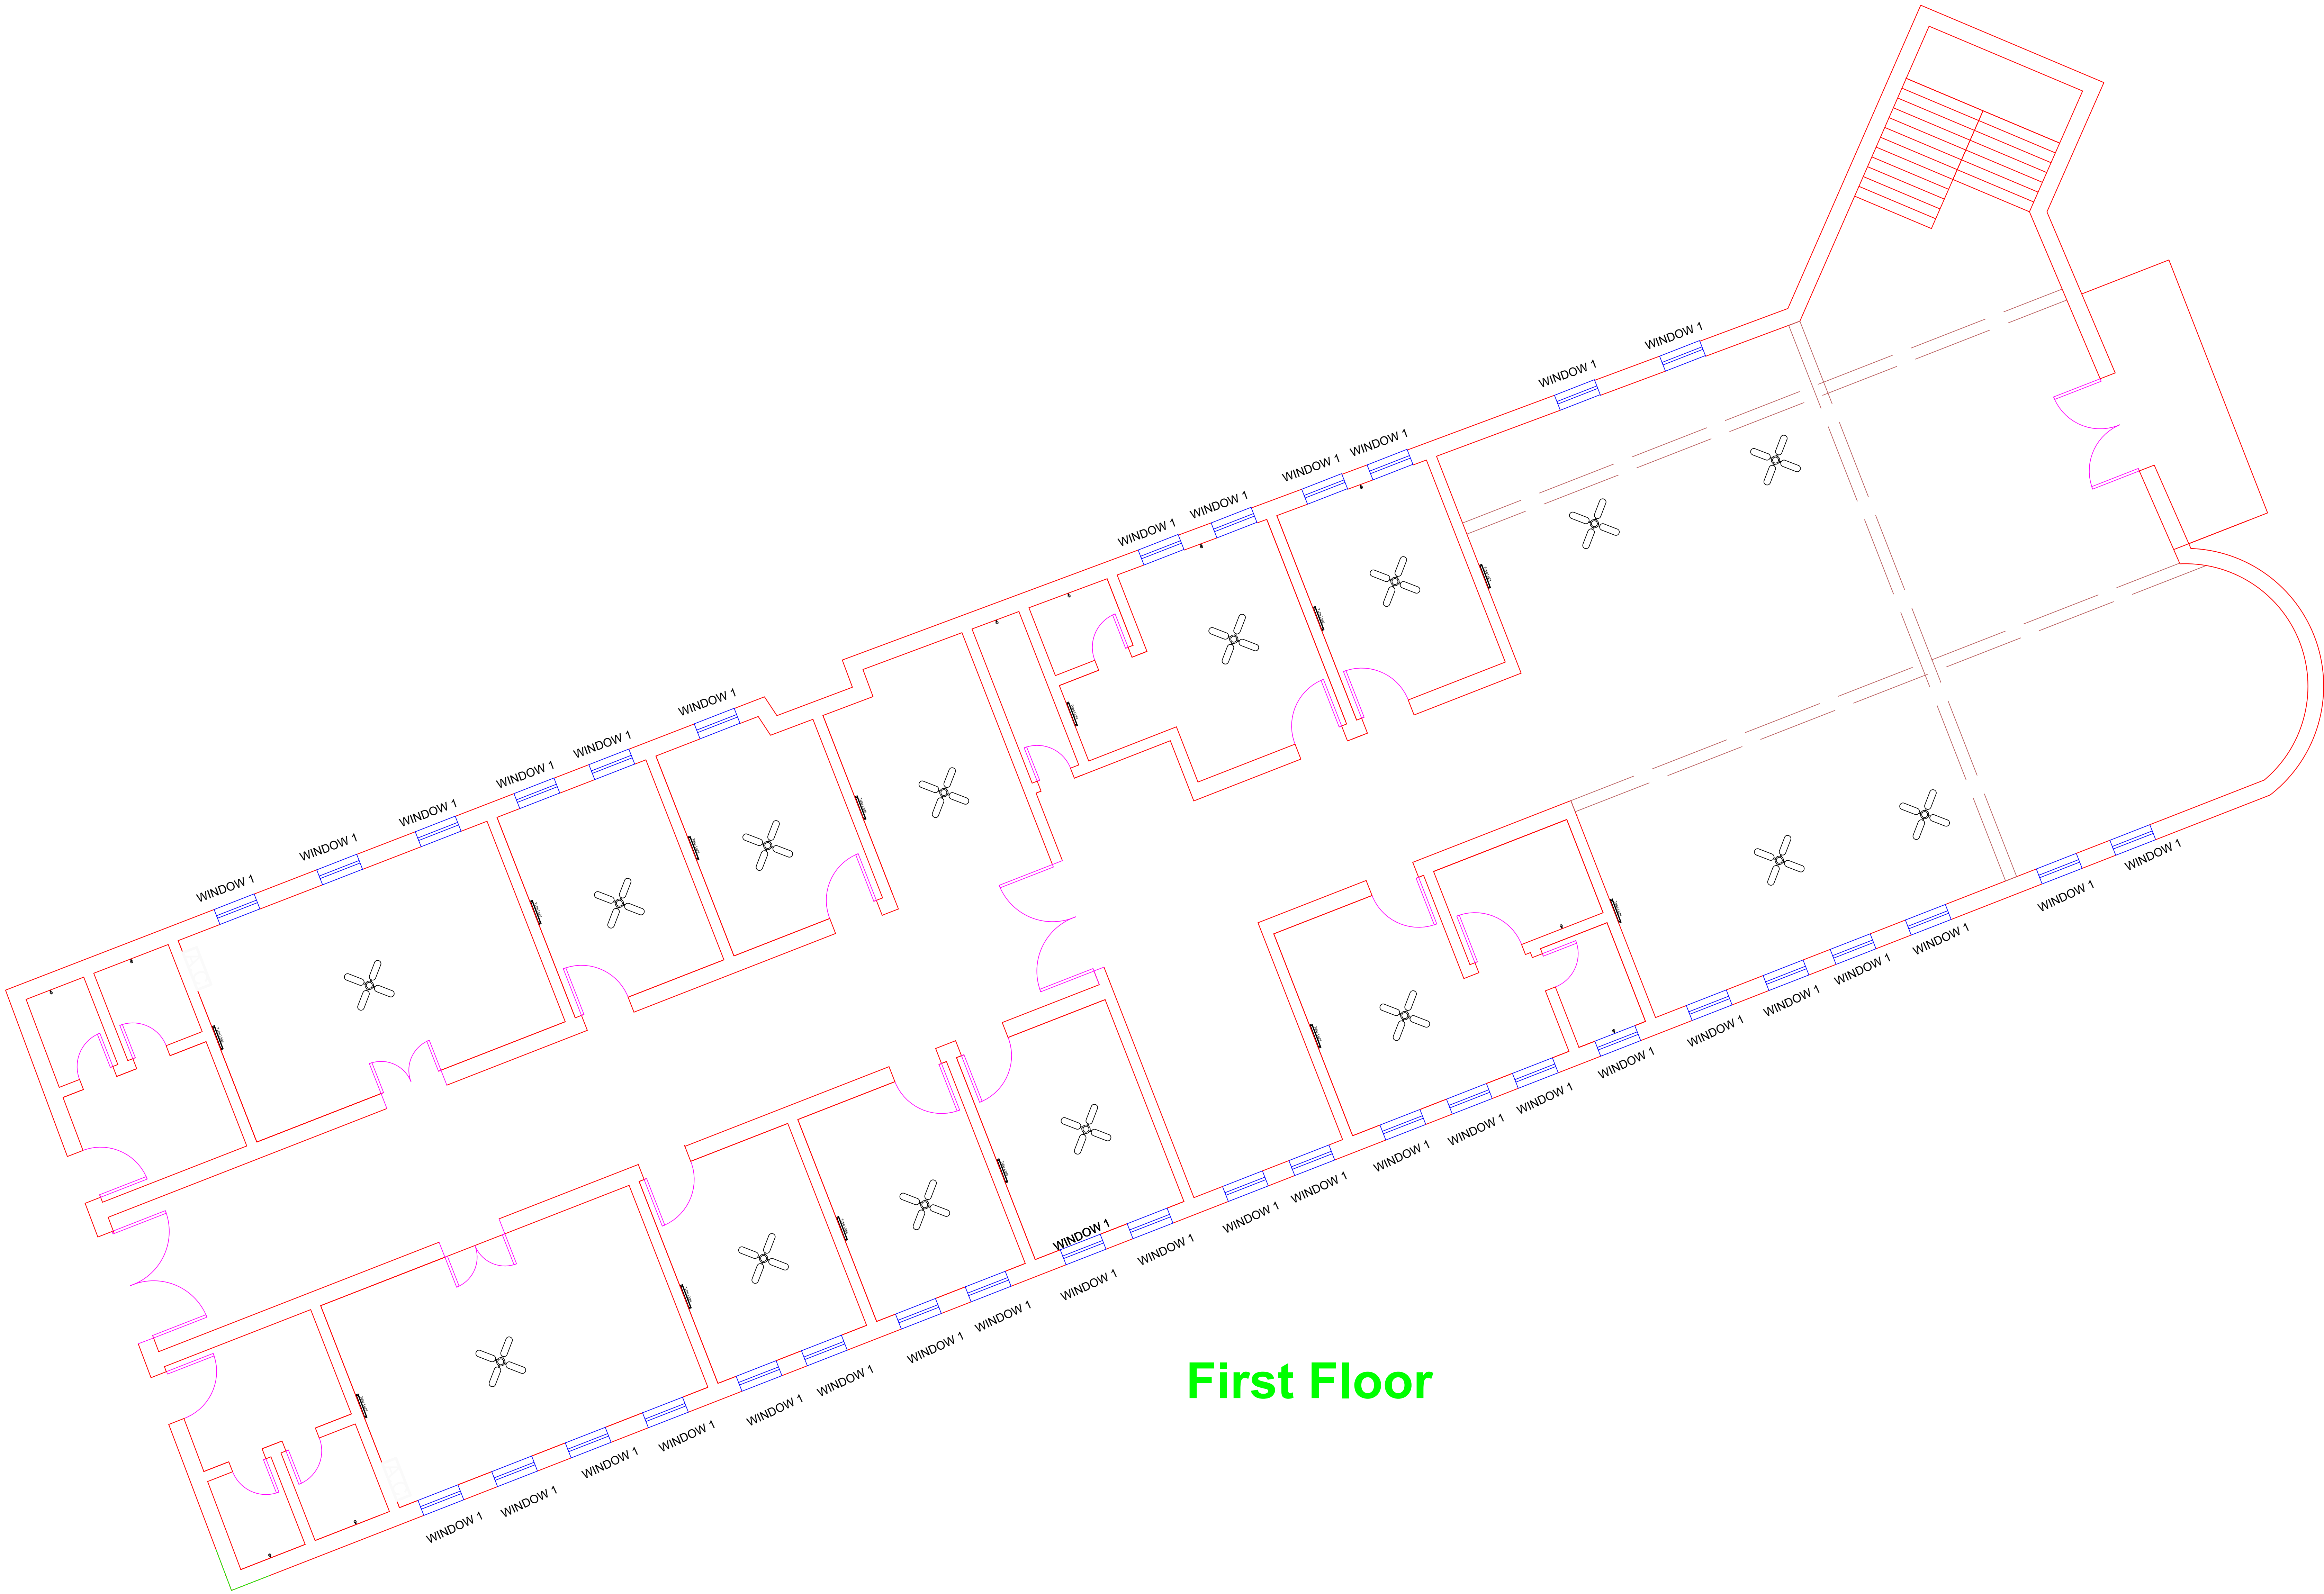

**Legends:**

Residential Area	
Road	
Wall	
Power Line	
OHT	
Tree	
ManHole	
Tube Well	
Light Pole	
Lawns	
Earthen Areas	
Asphalts Roads	
Tough Pavers	
P.C.C./Plinth Protection	
Boundary Wall	
Tap	
Hand Pump	
BRICK Pavers	
Air Conditioner	
Tube Light	
Fan	
Roof Light	
Bulb	

AREA	
AREA WITHIN BOUNDARY WALL	122241.3 Sft
AREA OF CLINICAL BLOCK	30403.64 Sft
PLINTH AREA OF BLOCK	23313.64 Sft

OPENING SCHEDULE OF DOORS AND WINDOWS					
DOORS	WIDTH	HEIGHT	WINDOWS	WIDTH	HEIGHT
D1	8'-0"	7'-0"	W1	3'-0"	5'-0"
D2	4'-6"	7'-0"	W2	4'-0"	4'-0"
D3	3'-0"	7'-0"	W3		
D4	3'-6"	7'-0"	W4		
D5	2'-6"	7'-0"	W5		
D6			W6		
D7			W7		
D8			V1		
D9			V2		

Client:



GOVERNMENT OF THE PUNJAB  
PRIMARY & SECONDARY  
HEALTHCARE DEPARTMENT

Project:

CAD MAPPING OF TEHSIL  
HEAD QUARTER HOSPITALS,  
PUNJAB

Consultant:



SKAFS CONSULTANT (Pvt.) Limited  
ENGINEERING AND ENVIRONMENT CONSULTANT

Drawing Title:

THQ MAILSI  
ELECTRICAL LAYOUT  
FIRST FLOOR

Authorized By: SKAFS	Reviewed By Co-Team Leader	Scale:
Prepared By: CAD TEAMS	Date: FEB, 2017	
Drawing No.		