


PART 1

PART 2

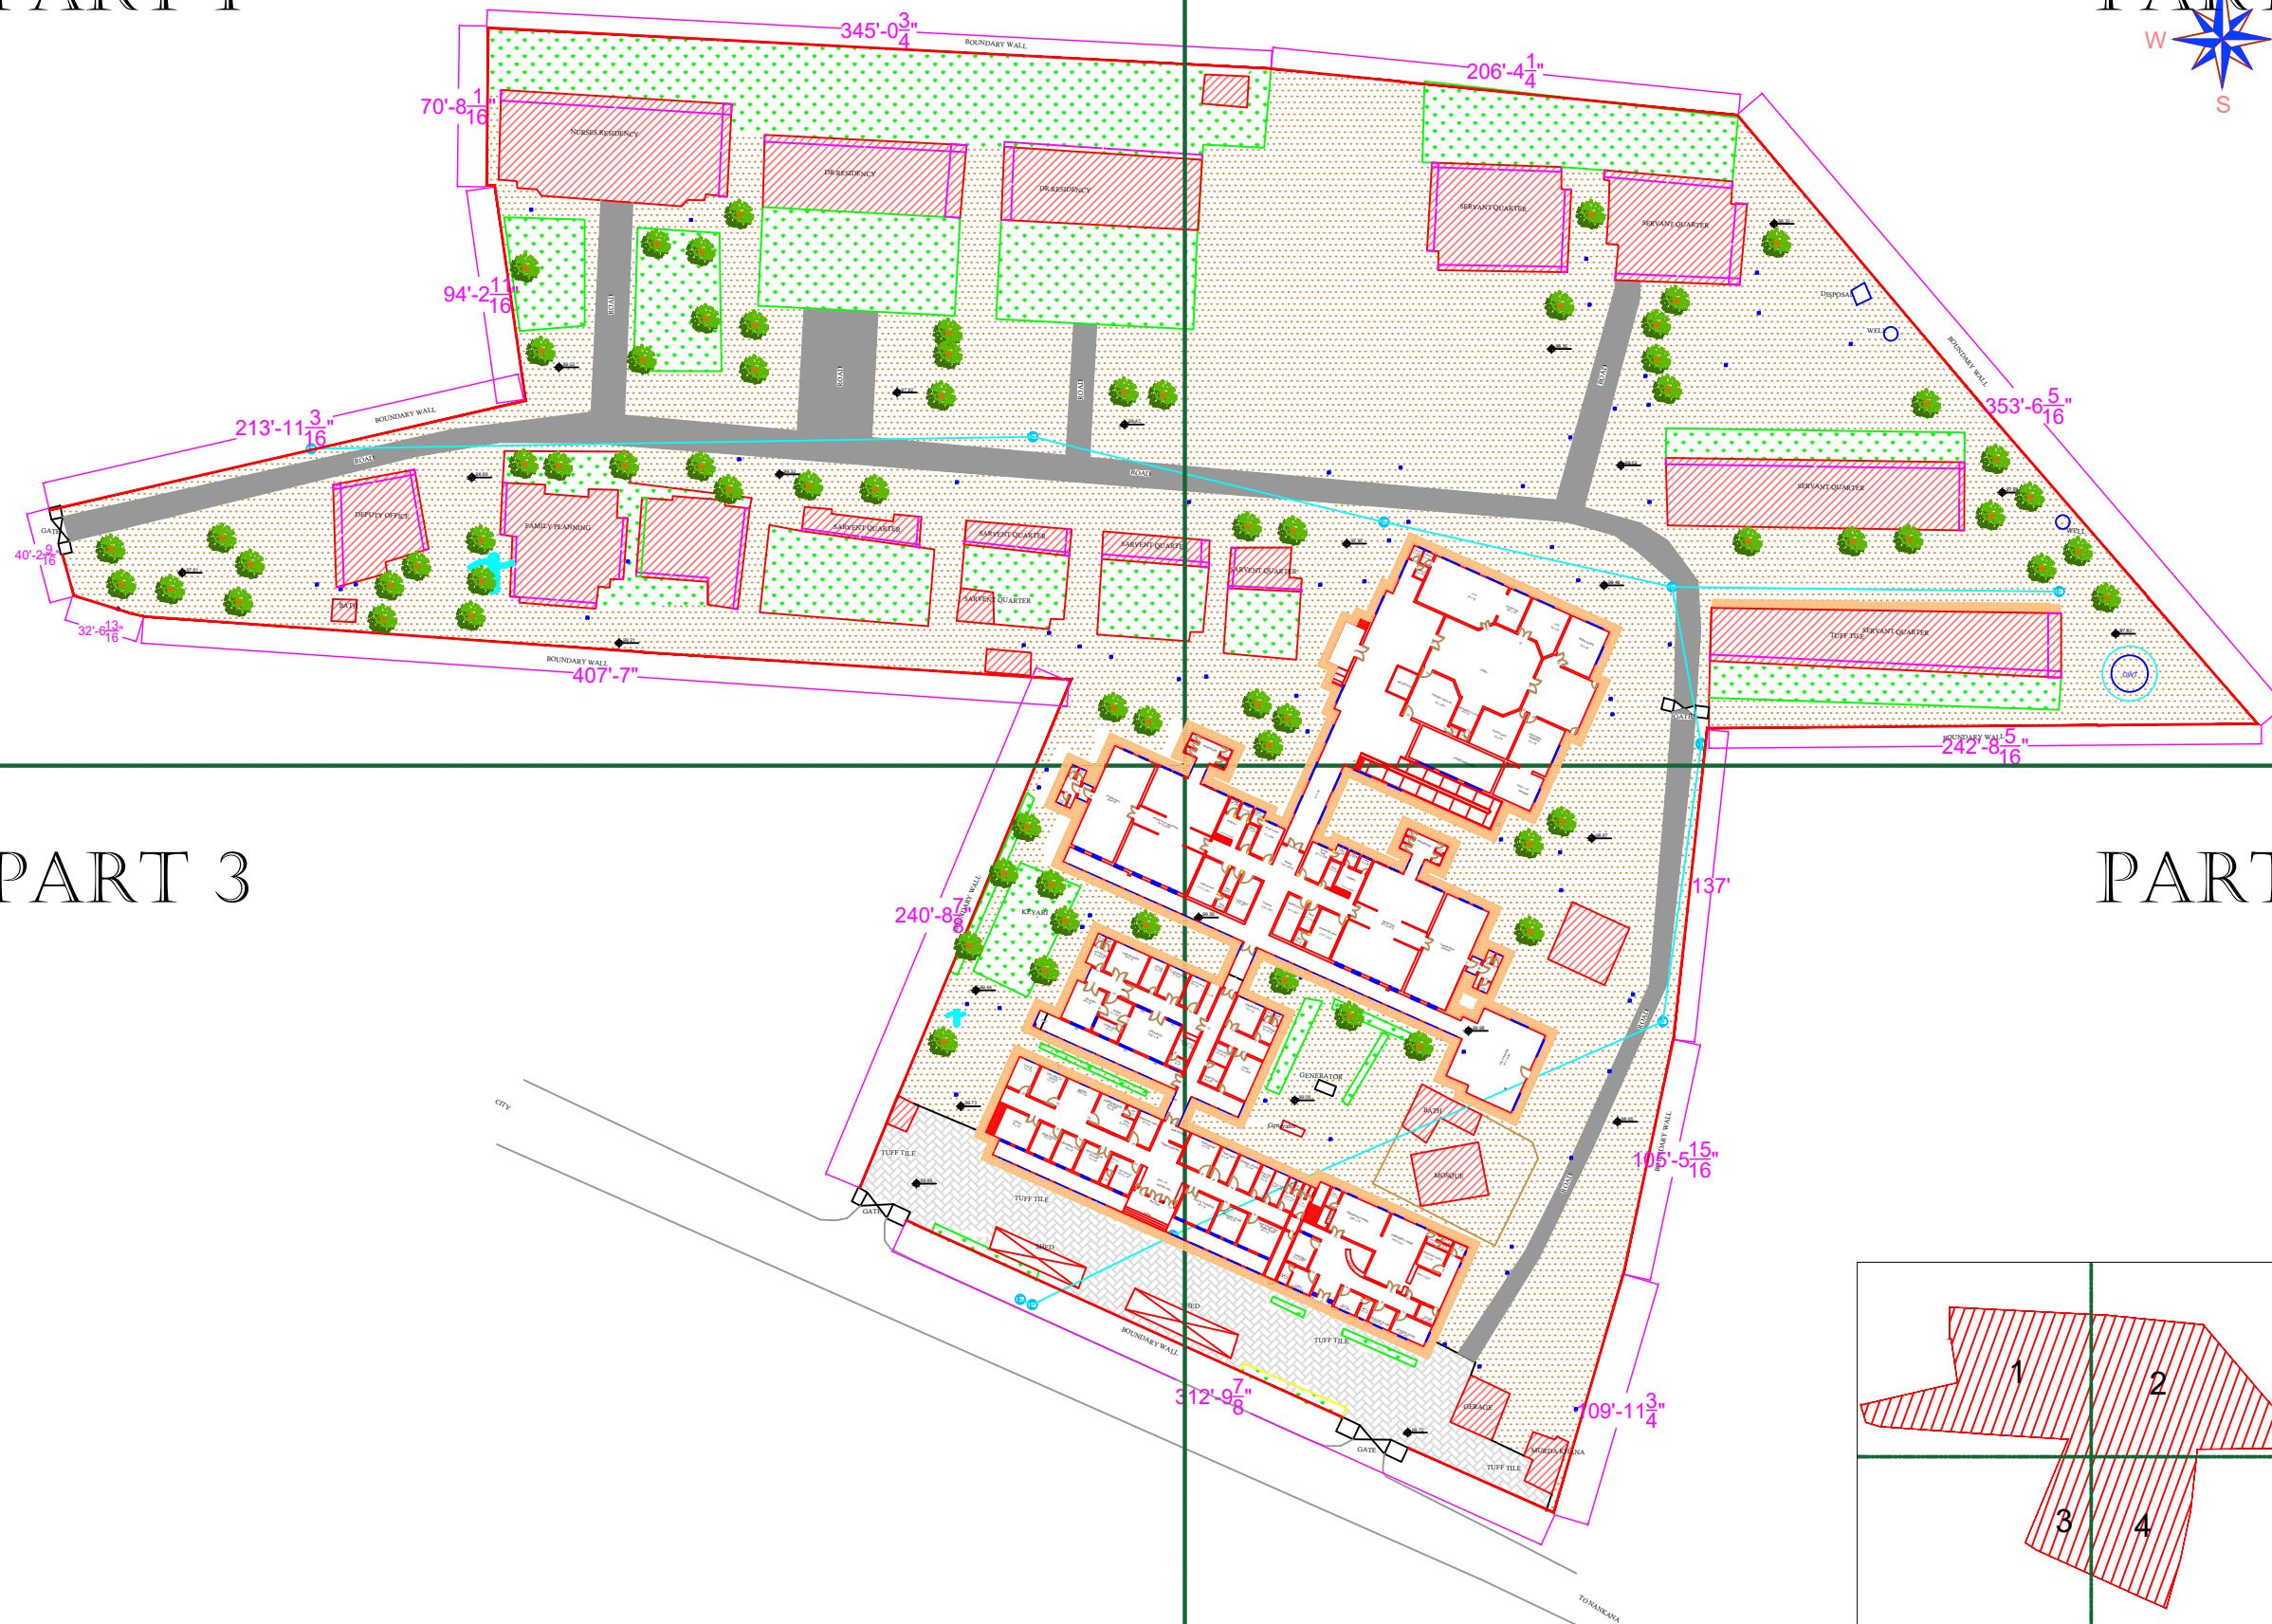



PART 3

PART 4







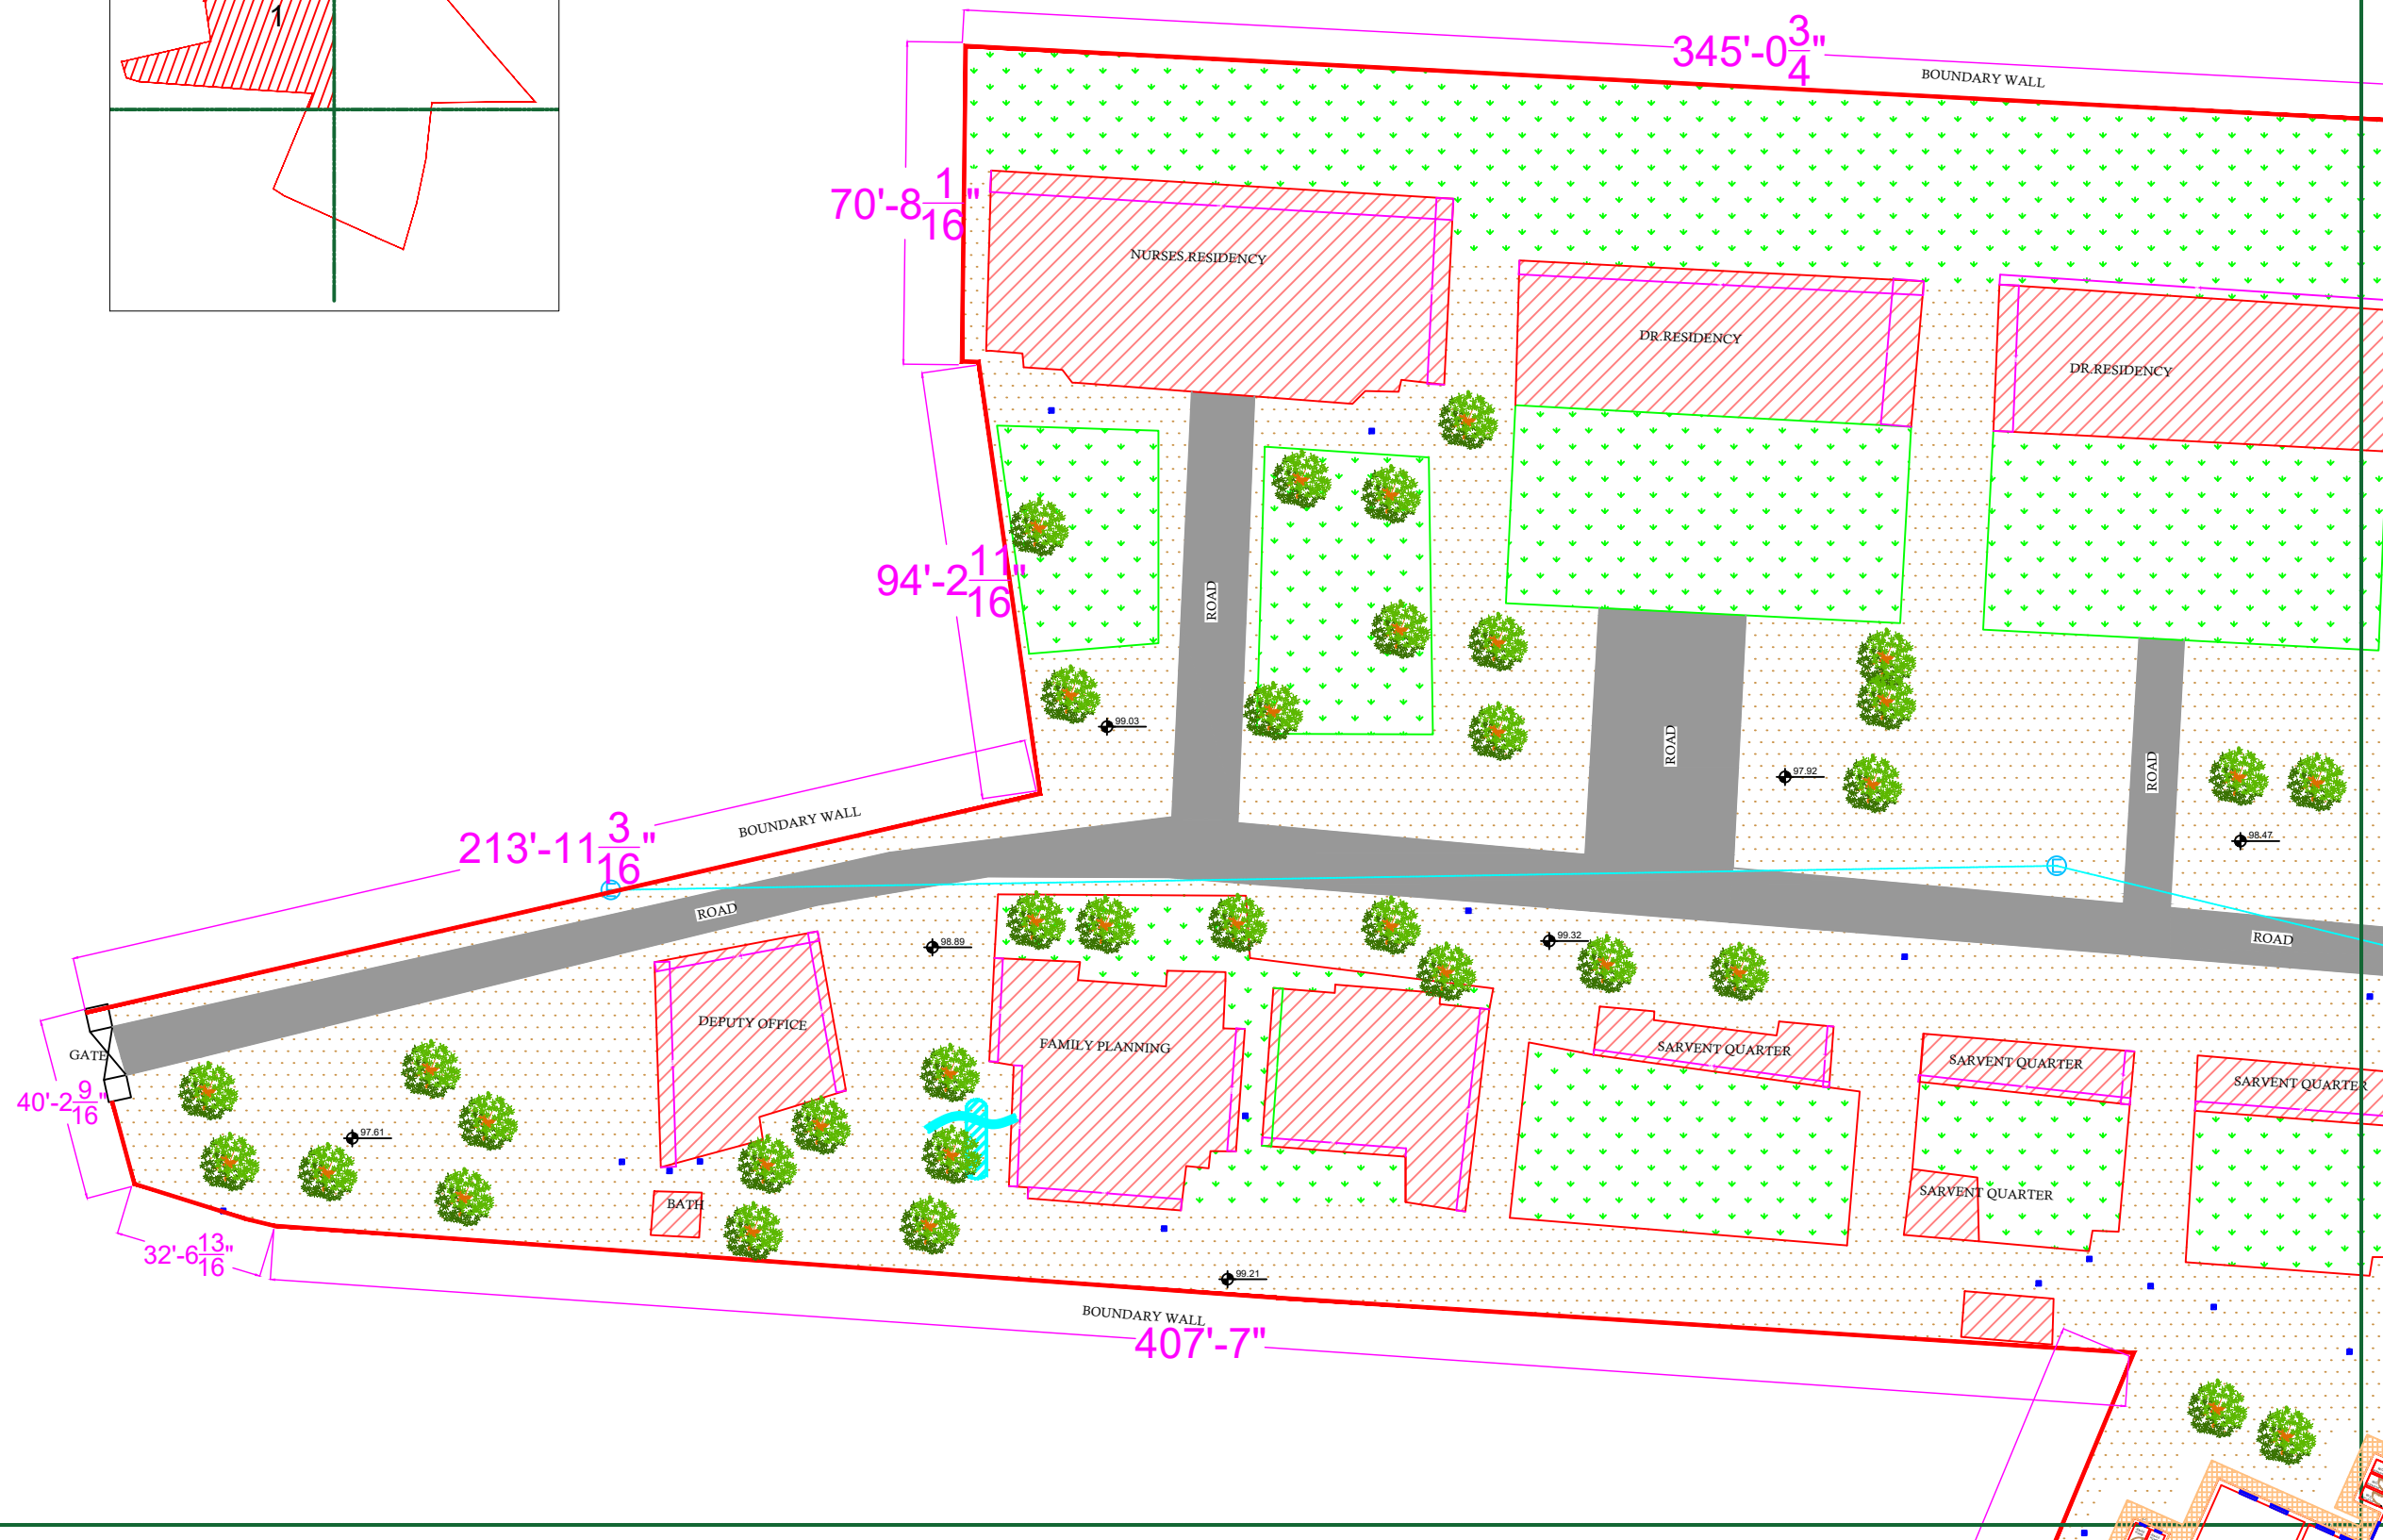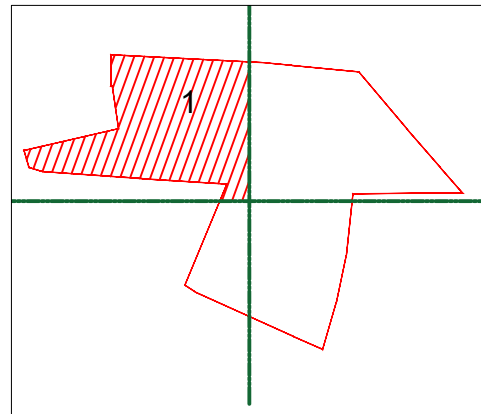








 







 
Drawing No. SKAFS/JARANWALA/03

MASTER PLAN OF THQ HOSPITAL JARANWALA

PART 1





Legends:

Residential Area	
Road	
Wall	
Power Line	
OHT	
Tree	
Man Hole	
Tube Well	
Light Pole	
Lawns	
Earthen Areas	
Asphalts Roads	
Tough Pavers	
P.C.C / Plinth Protection	
Boundary Wall	
Brick Pavers / Soling	
Drain	
Tap	
Hand Pump	
Air Conditioner	
Tube Light	
Fan	
Roof Light	
Bulb	

AREA	
AREA WITHIN BOUNDARY WALL	286049.88 Sft
AREA OF CLINICAL BLOCK	51250.88 Sft
PLINTH AREA OF BLOCK	39354.48 Sft

[illegible]

Project:
**CAD MAPPING OF TEHSIL
HEAD QUARTER HOSPITALS,
PUNJAB**


<p>Client:</p>  <p>GOVERNMENT OF THE PUNJAB PRIMARY & SECONDARY HEALTHCARE DEPARTMENT</p>	<p>Consultant:</p>  <p>SKAFS CONSULTANT (Pvt.) Limited <i>ENGINEERING AND ENVIRONMENT</i></p>
--	--

Drawing Title: **THQ JARANWALA
HOSPITAL MASTER PLAN PART 1**

Drawing No. SKAFS/JARANWALA/04

MASTER PLAN OF THQ HOSPITAL JARANWALA

PART 2

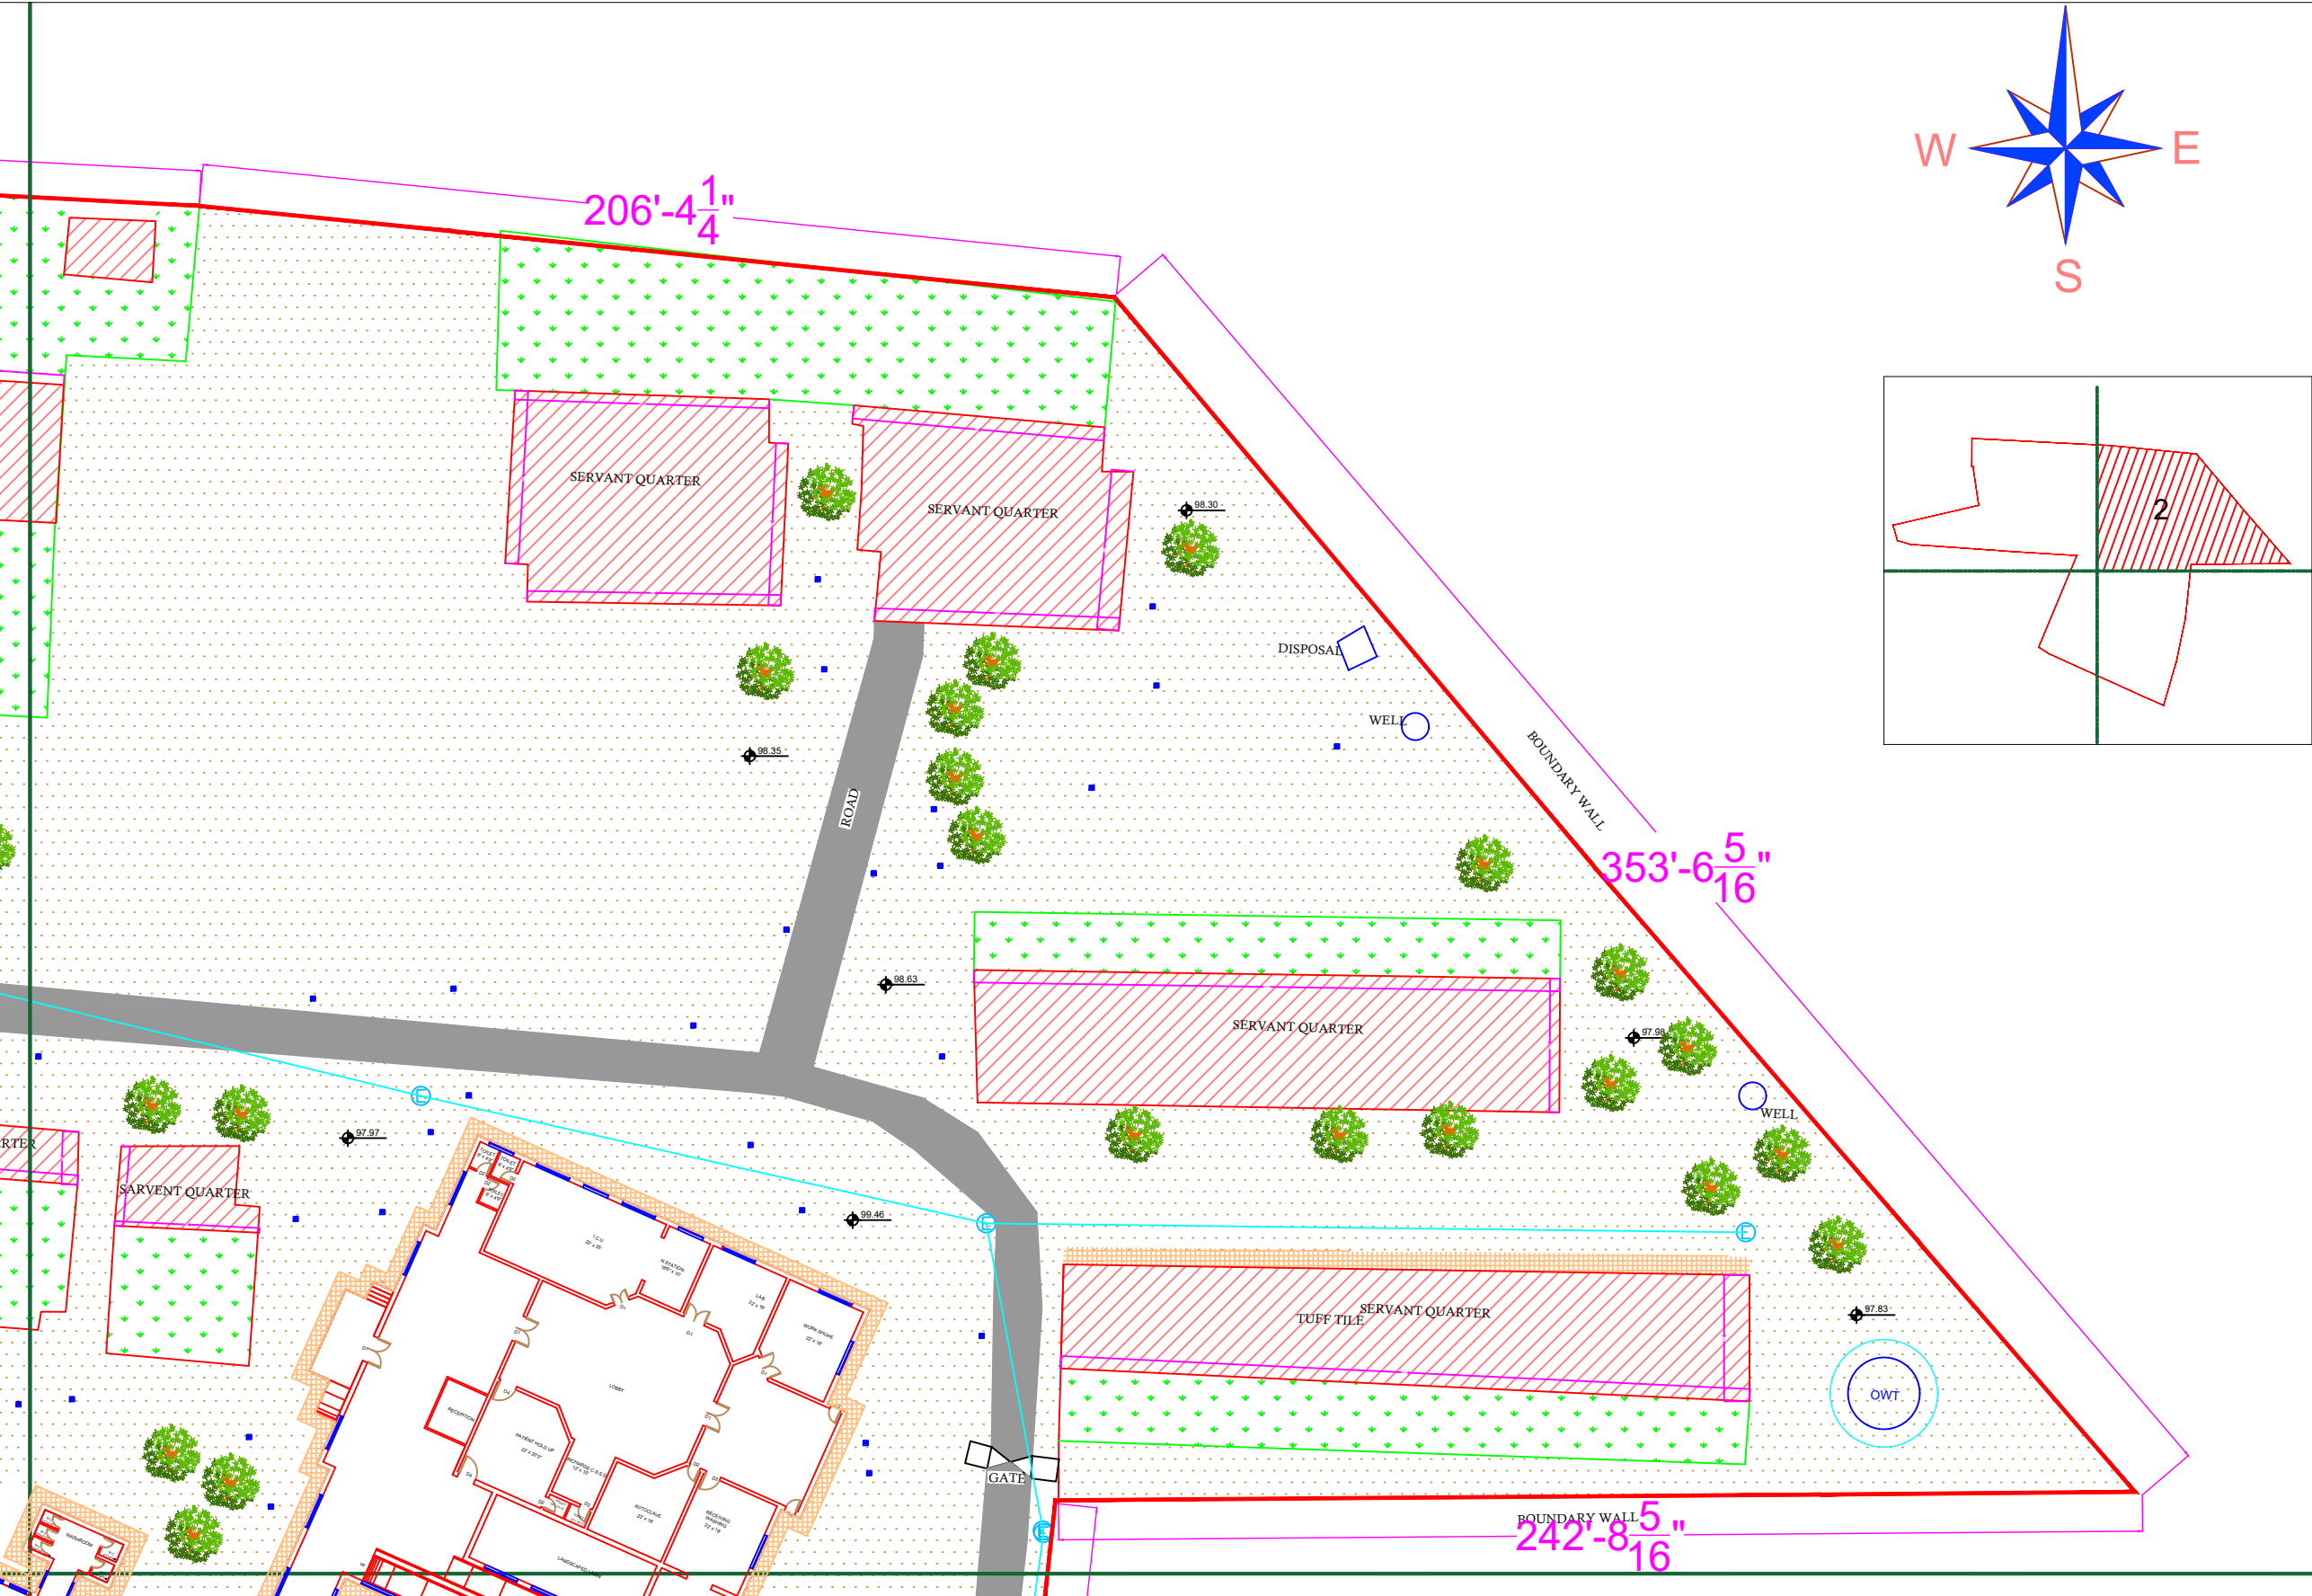

Legends:

Residential Area	
Road	
Wall	
Power Line	
OHT	
Tree	
Man Hole	
Tube Well	
Light Pole	
Lawns	
Earthen Areas	
Asphalts Roads	
Tough Pavers	
P.C.C / Plinth Protection	
Boundary Wall	
Brick Pavers / Soling	
Drain	
Tap	
Hand Pump	
Air Conditioner	
Tube Light	
Fan	
Roof Light	
Bulb	

AREA					
AREA WITHIN BOUNDARY WALL		286049.88 Sft			
AREA OF CLINICAL BLOCK		51250.88 Sft			
PLINTH AREA OF BLOCK		39354.48 Sft			

OPENING SCHEDULE OF DOORS AND WINDOWS					
DOORS	WIDTH	HEIGHT	WINDOWS	WIDTH	HEIGHT
D1	5'-0"	7'-0"	W1	4'-0"	4'-0"
D2	2'-6"	7'-0"	W2	6'-0"	6'-0"
D3	3'-6"	7'-0"	W3	8'-0"	8'-0"
D4	4'-0"	7'-0"	V1	1'-6"	1'-6"

Project:
**CAD MAPPING OF TEHSIL
HEAD QUARTER HOSPITALS,
PUNJAB**

Client:

GOVERNMENT OF THE PUNJAB
PRIMARY & SECONDARY
HEALTHCARE DEPARTMENT



Consultant:

SKAFS CONSULTANT (Pvt.)
Limited
ENGINEERING AND ENVIRONMENT
CONSULTANT







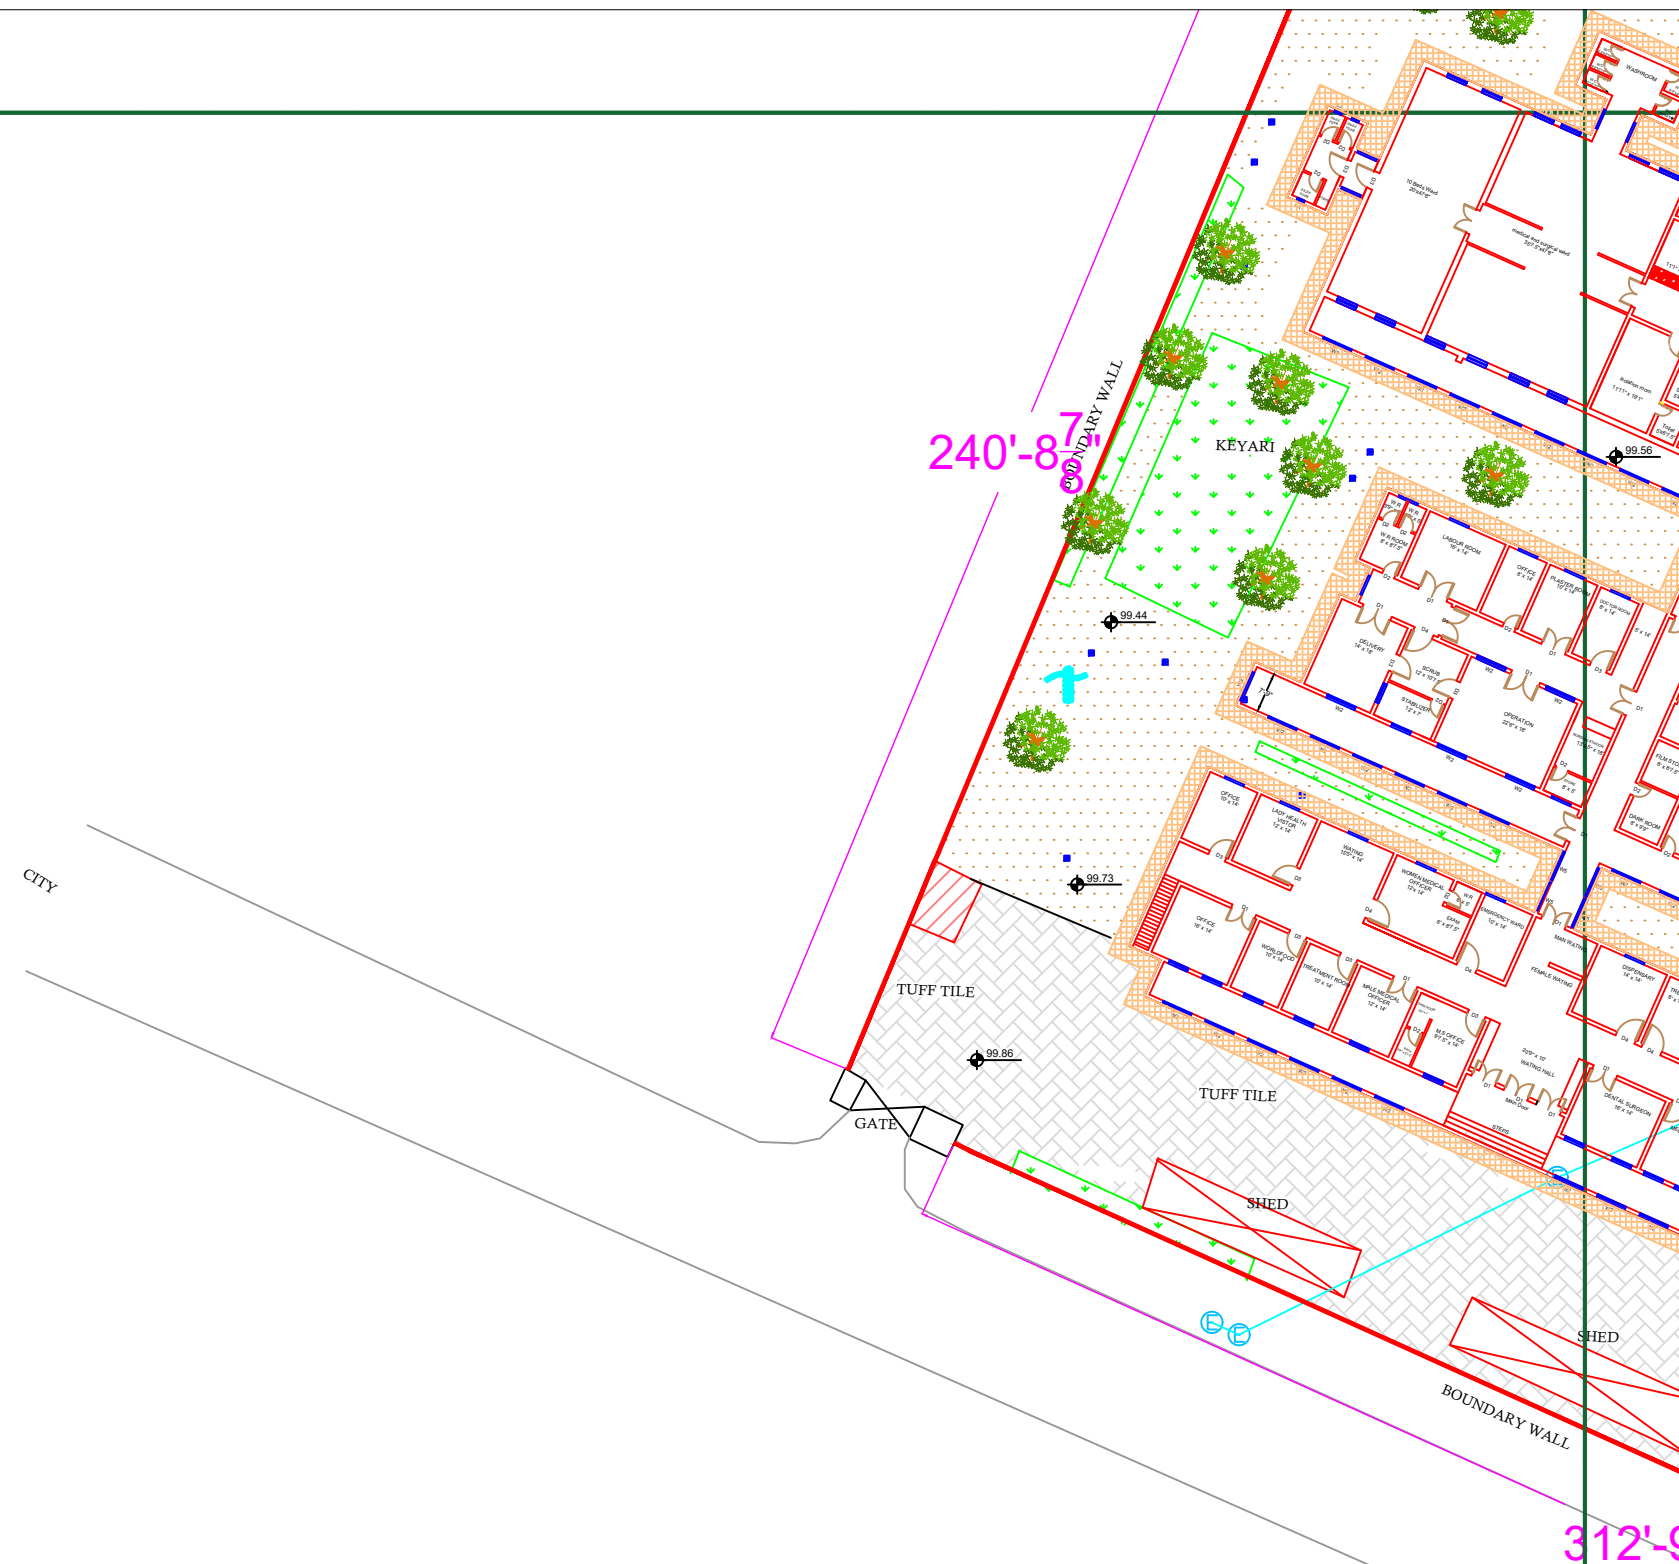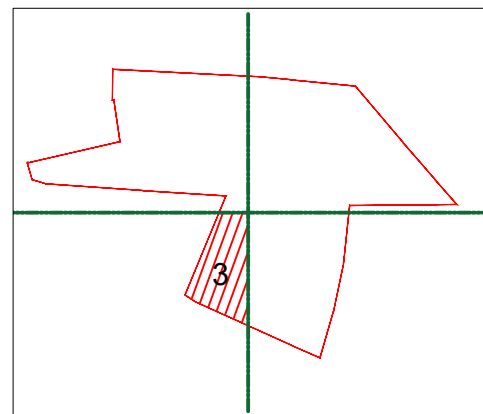












 




Drawing Title:
**THQ JARANWALA
HOSPITAL MASTER PLAN PART 2**

Drawing No.
SKAFS/JARANWALA/05

MASTER PLAN OF THQ HOSPITAL JARANWALA
PART 3




 
Legends:

Residential Area	
Road	
Wall	
Power Line	
OHT	
Tree	
Man Hole	
Tube Well	
Light Pole	
Lawns	
Earthen Areas	
Asphalts Roads	
Tough Pavers	
P.C.C / Plinth Protection	
Boundary Wall	
Brick Pavers / Soling	
Drain	
Tap	
Hand Pump	
Air Conditioner	
Tube Light	
Fan	
Roof Light	
Bulb	

AREA	
AREA WITHIN BOUNDARY WALL	286049.88 Sft
AREA OF CLINICAL BLOCK	51250.88 Sft
PLINTH AREA OF BLOCK	39354.48 Sft

[illegible]

Project: **CAD MAPPING OF TEHSIL
HEAD QUARTER HOSPITALS,
PUNJAB**


<p>Client:</p>  <p>GOVERNMENT OF THE PUNJAB PRIMARY & SECONDARY HEALTHCARE DEPARTMENT</p>	<p>Consultant:</p>  <p>SKAFS CONSULTANT (Pvt.) Limited <i>ENGINEERING AND ENVIRONMENT CONSULTANT</i></p>
--	---

Drawing Title: **THQ JARANWALA
HOSPITAL MASTER PLAN PART 3**

Drawing No. **SKAFS/JARANWALA/06**

MASTER PLAN OF THQ HOSPITAL JARANWALA

PART 4

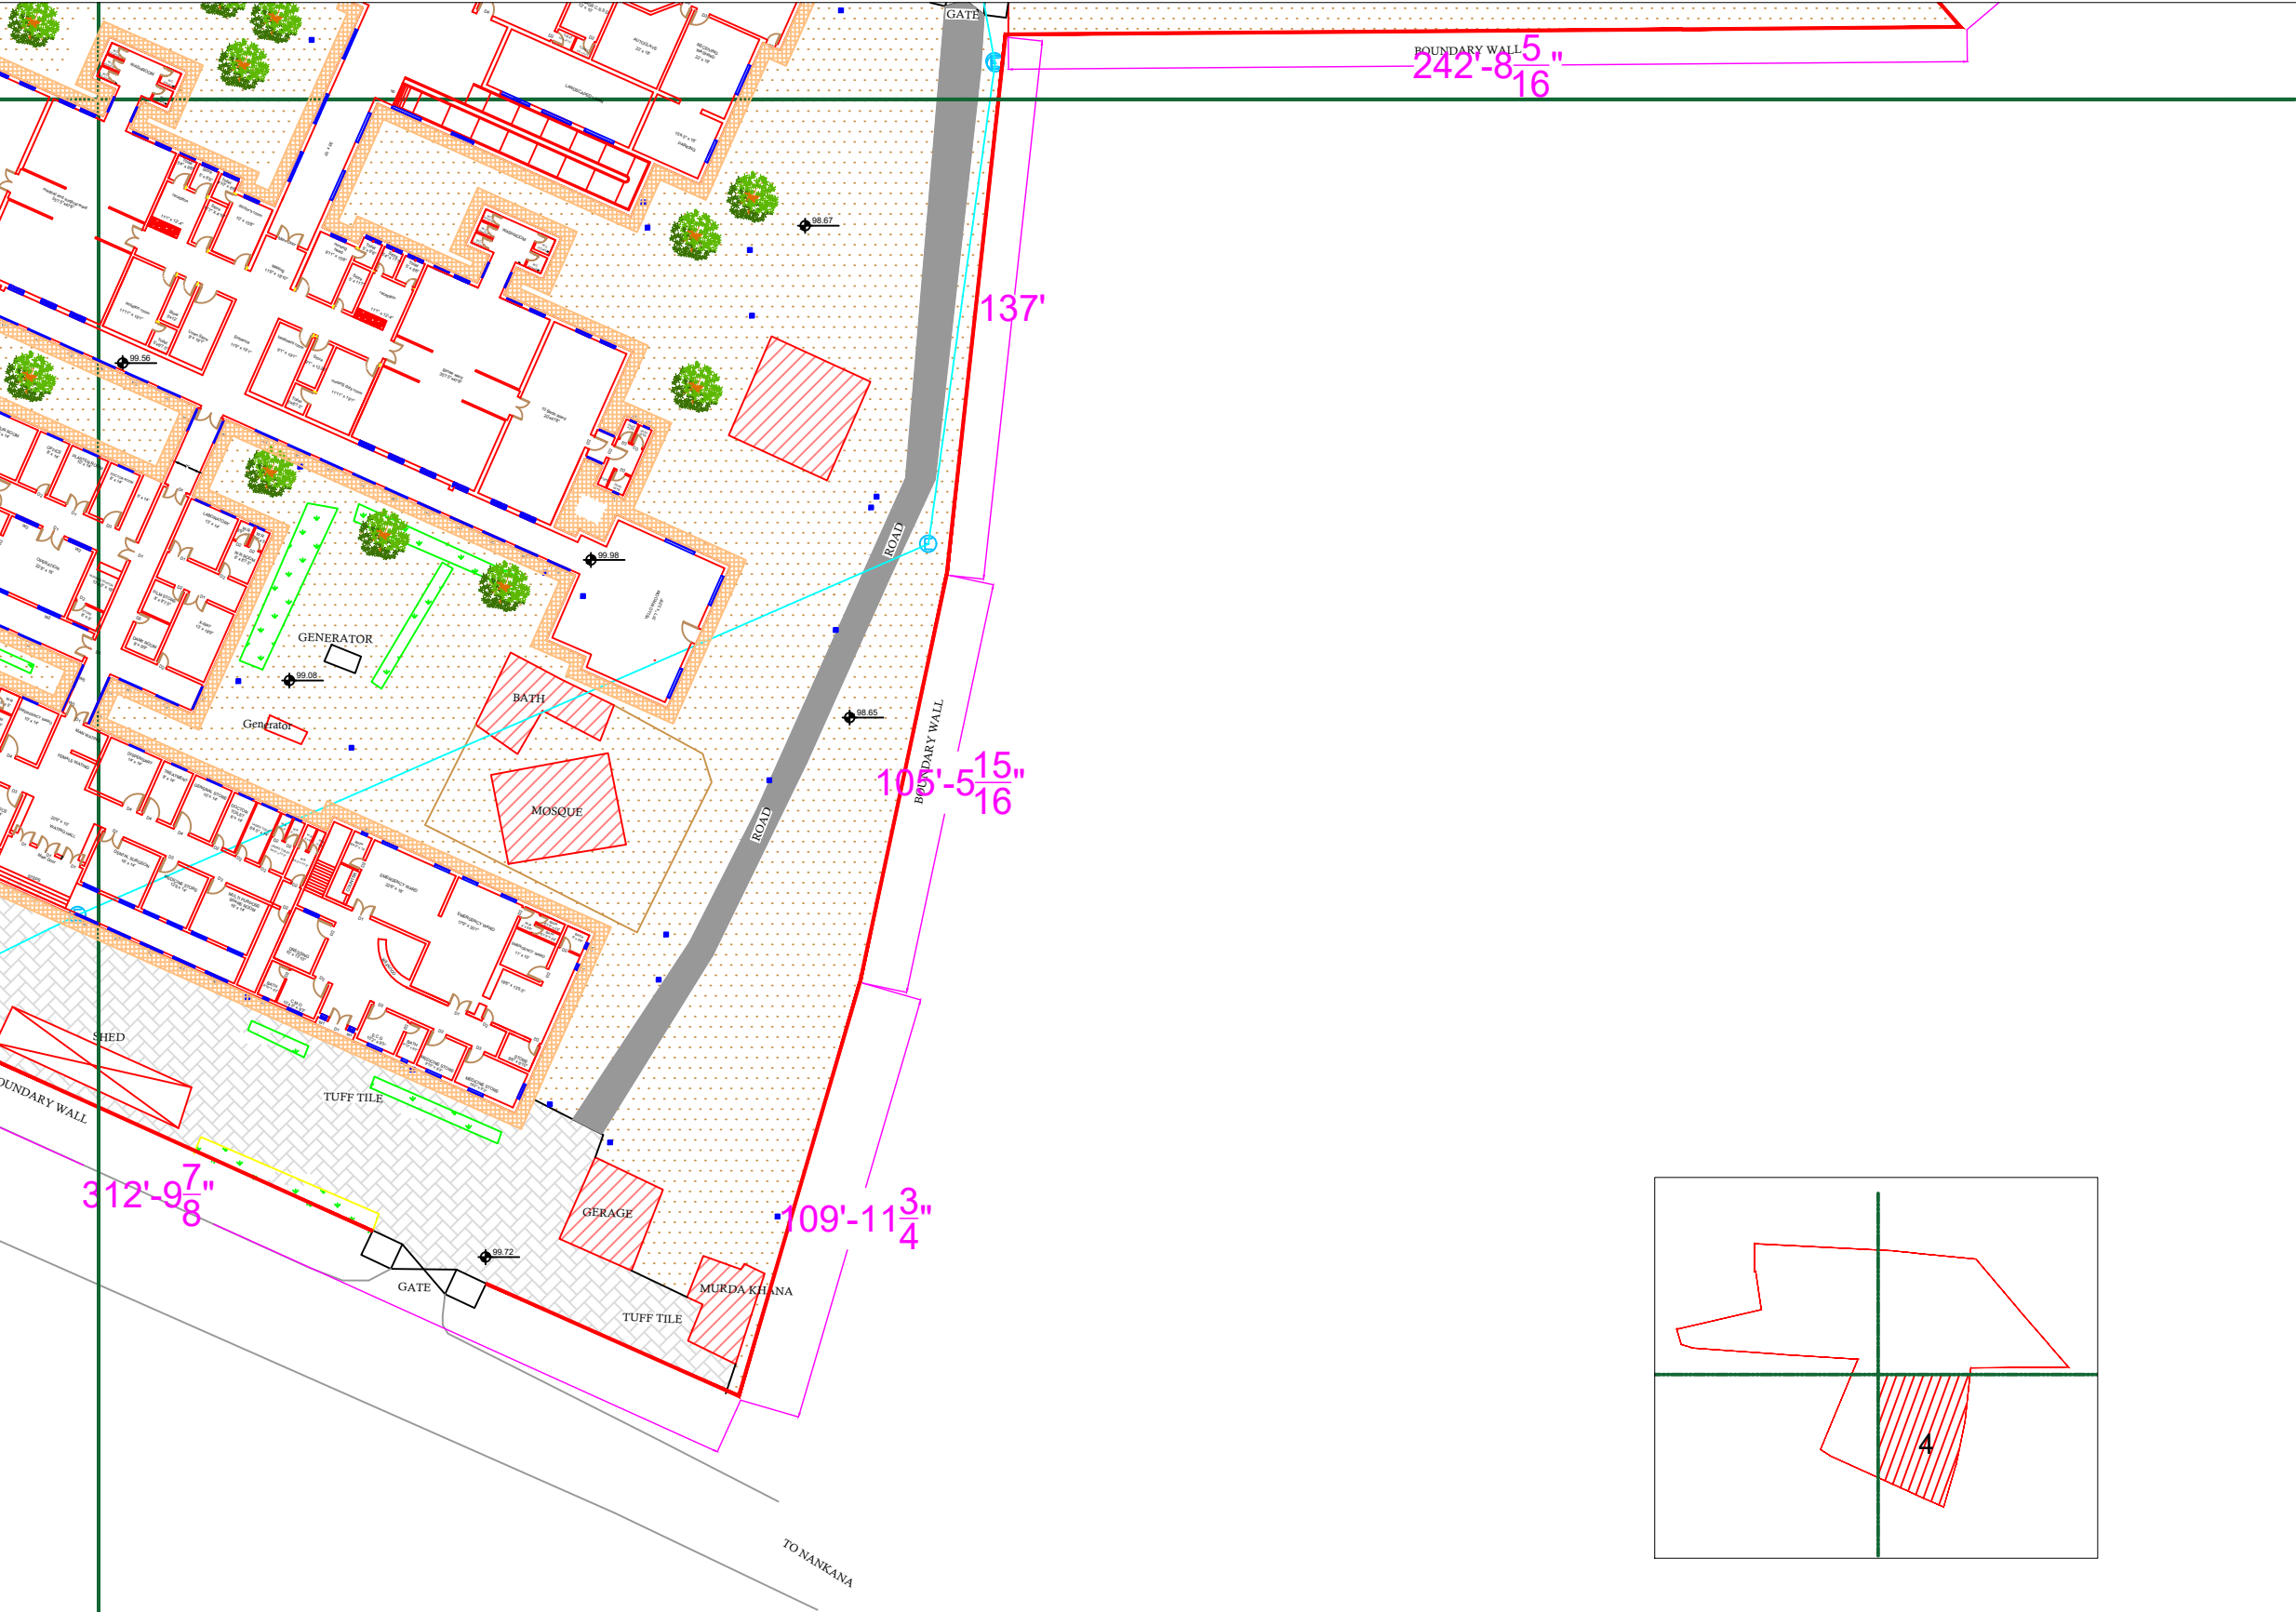

Legends:

Residential Area	
Road	
Wall	
Power Line	
OHT	
Tree	
Man Hole	
Tube Well	
Light Pole	
Lawns	
Earthen Areas	
Asphalts Roads	
Tough Pavers	
P.C.C / Plinth Protection	
Boundary Wall	
Brick Pavers / Soling	
Drain	
Tap	
Hand Pump	
Air Conditioner	
Tube Light	
Fan	
Roof Light	
Bulb	

AREA	
AREA WITHIN BOUNDARY WALL	286049.88 Sft
AREA OF CLINICAL BLOCK	51250.88 Sft
PLINTH AREA OF BLOCK	39354.48 Sft

OPENING SCHEDULE OF DOORS AND WINDOWS					
DOORS	WIDTH	HEIGHT	WINDOWS	WIDTH	HEIGHT
D1	5'-0"	7'-0"	W1	4'-0"	4'-0"
D2	2'-6"	7'-0"	W2	6'-0"	6'-0"
D3	3'-6"	7'-0"	W3	8'-0"	8'-0"
D4	4'-0"	7'-0"	V1	1'-6"	1'-6"

Project:
**CAD MAPPING OF TEHSIL
HEAD QUARTER HOSPITALS,
PUNJAB**

Client:

GOVERNMENT OF THE PUNJAB
PRIMARY & SECONDARY
HEALTHCARE DEPARTMENT

Consultant:


SKAFS CONSULTANT (Pvt.)
Limited
ENGINEERING AND ENVIRONMENT
CONSULTANT

Drawing Title:
**THQ JARANWALA
HOSPITAL MASTER PLAN PART 4**







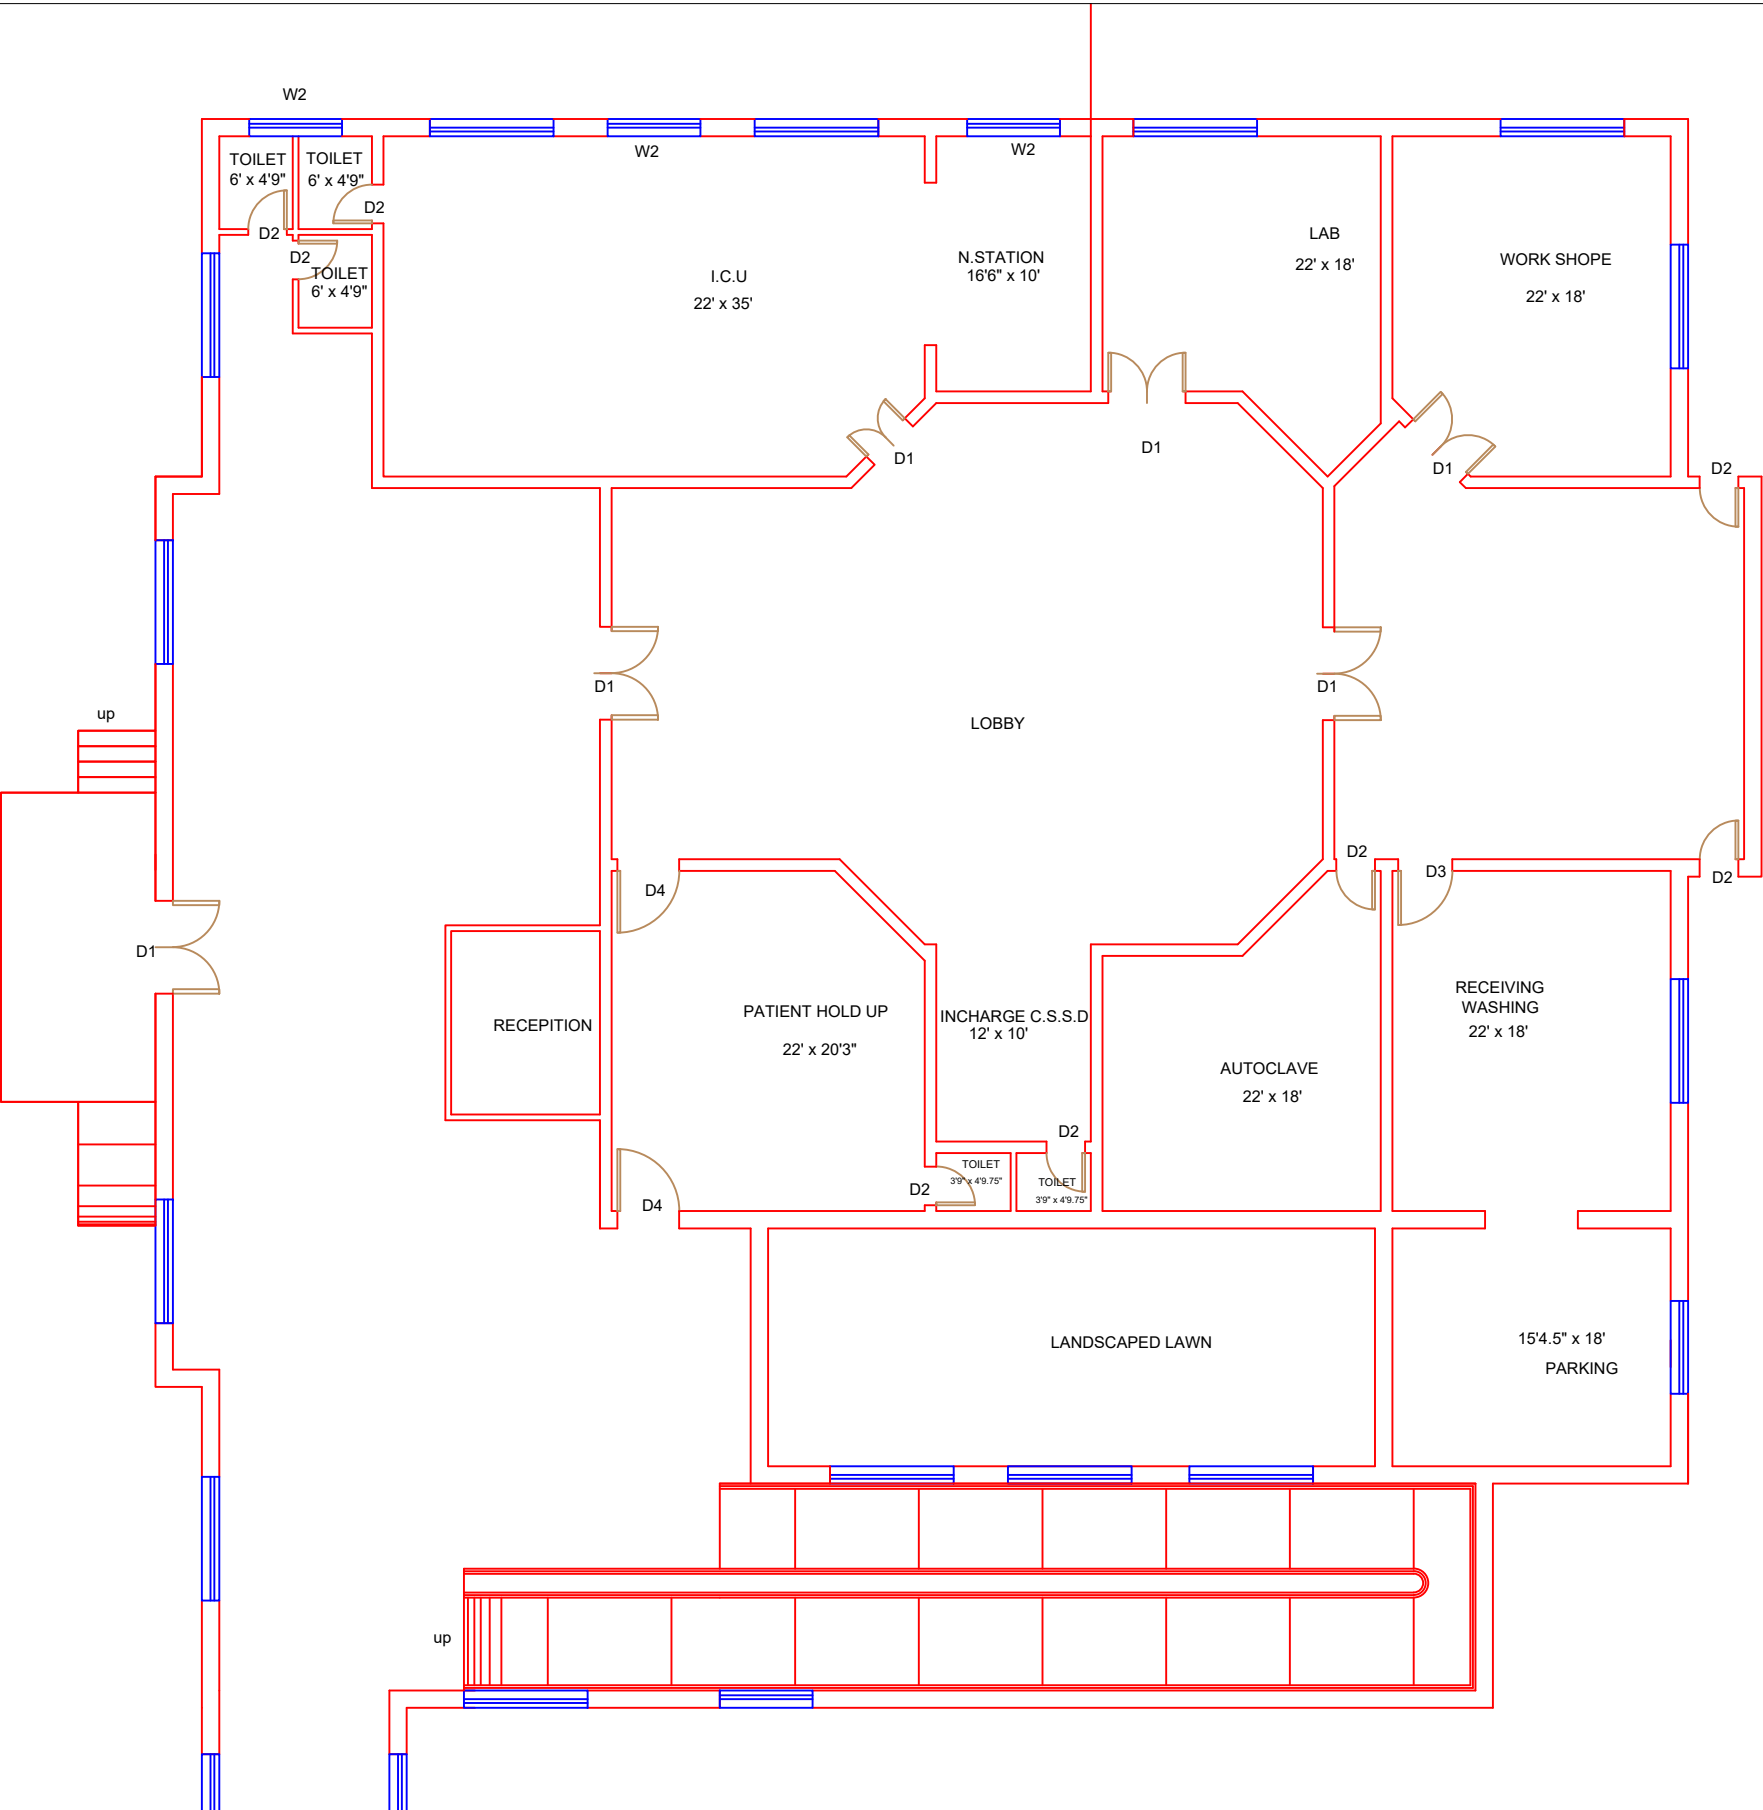












 




Drawing No.
SKAFS/JARANWALA/07

Drawing No.	SKAFS/JARANWALA/08
-------------	--------------------

CLINICAL BLOCK OF THQ HOSPITAL JARANWALA
GROUND FLOOR PART 1





Legends:

Residential Area	
Road	
Wall	
Power Line	
OHT	
Tree	
Man Hole	
Tube Well	
Light Pole	
Lawns	
Earthen Areas	
Asphalts Roads	
Tough Pavers	
P.C.C / Plinth Protection	
Boundary Wall	
Brick Pavers / Soling	
Drain	
Tap	
Hand Pump	
Air Conditioner	
Tube Light	
Fan	
Roof Light	
Bulb	

AREA	
AREA WITHIN BOUNDARY WALL	286049.88 Sft
AREA OF CLINICAL BLOCK	51250.88 Sft
PLINTH AREA OF BLOCK	39354.48 Sft

OPENING SCHEDULE OF DOORS AND WINDOWS					
DOORS	WIDTH	HEIGHT	WINDOWS	WIDTH	HEIGHT
D1	5'-0"	7'-0"	W1	4'-0"	4'-0"
D2	2'-6"	7'-0"	W2	6'-0"	6'-0"
D3	3'-6"	7'-0"	W3	8'-0"	8'-0"
D4	4'-0"	7'-0"	V1	1'-6"	1'-6"


Project:
**CAD MAPPING OF TEHSIL
HEAD QUARTER HOSPITALS,
PUNJAB**

<p>Client:</p>  <p>GOVERNMENT OF THE PUNJAB PRIMARY & SECONDARY HEALTHCARE DEPARTMENT</p>	<p>Consultant:</p>  <p>SKAFS CONSULTANT (Pvt.) Limited <i>ENGINEERING AND ENVIRONMENT CONSULTANT</i></p>
--	---









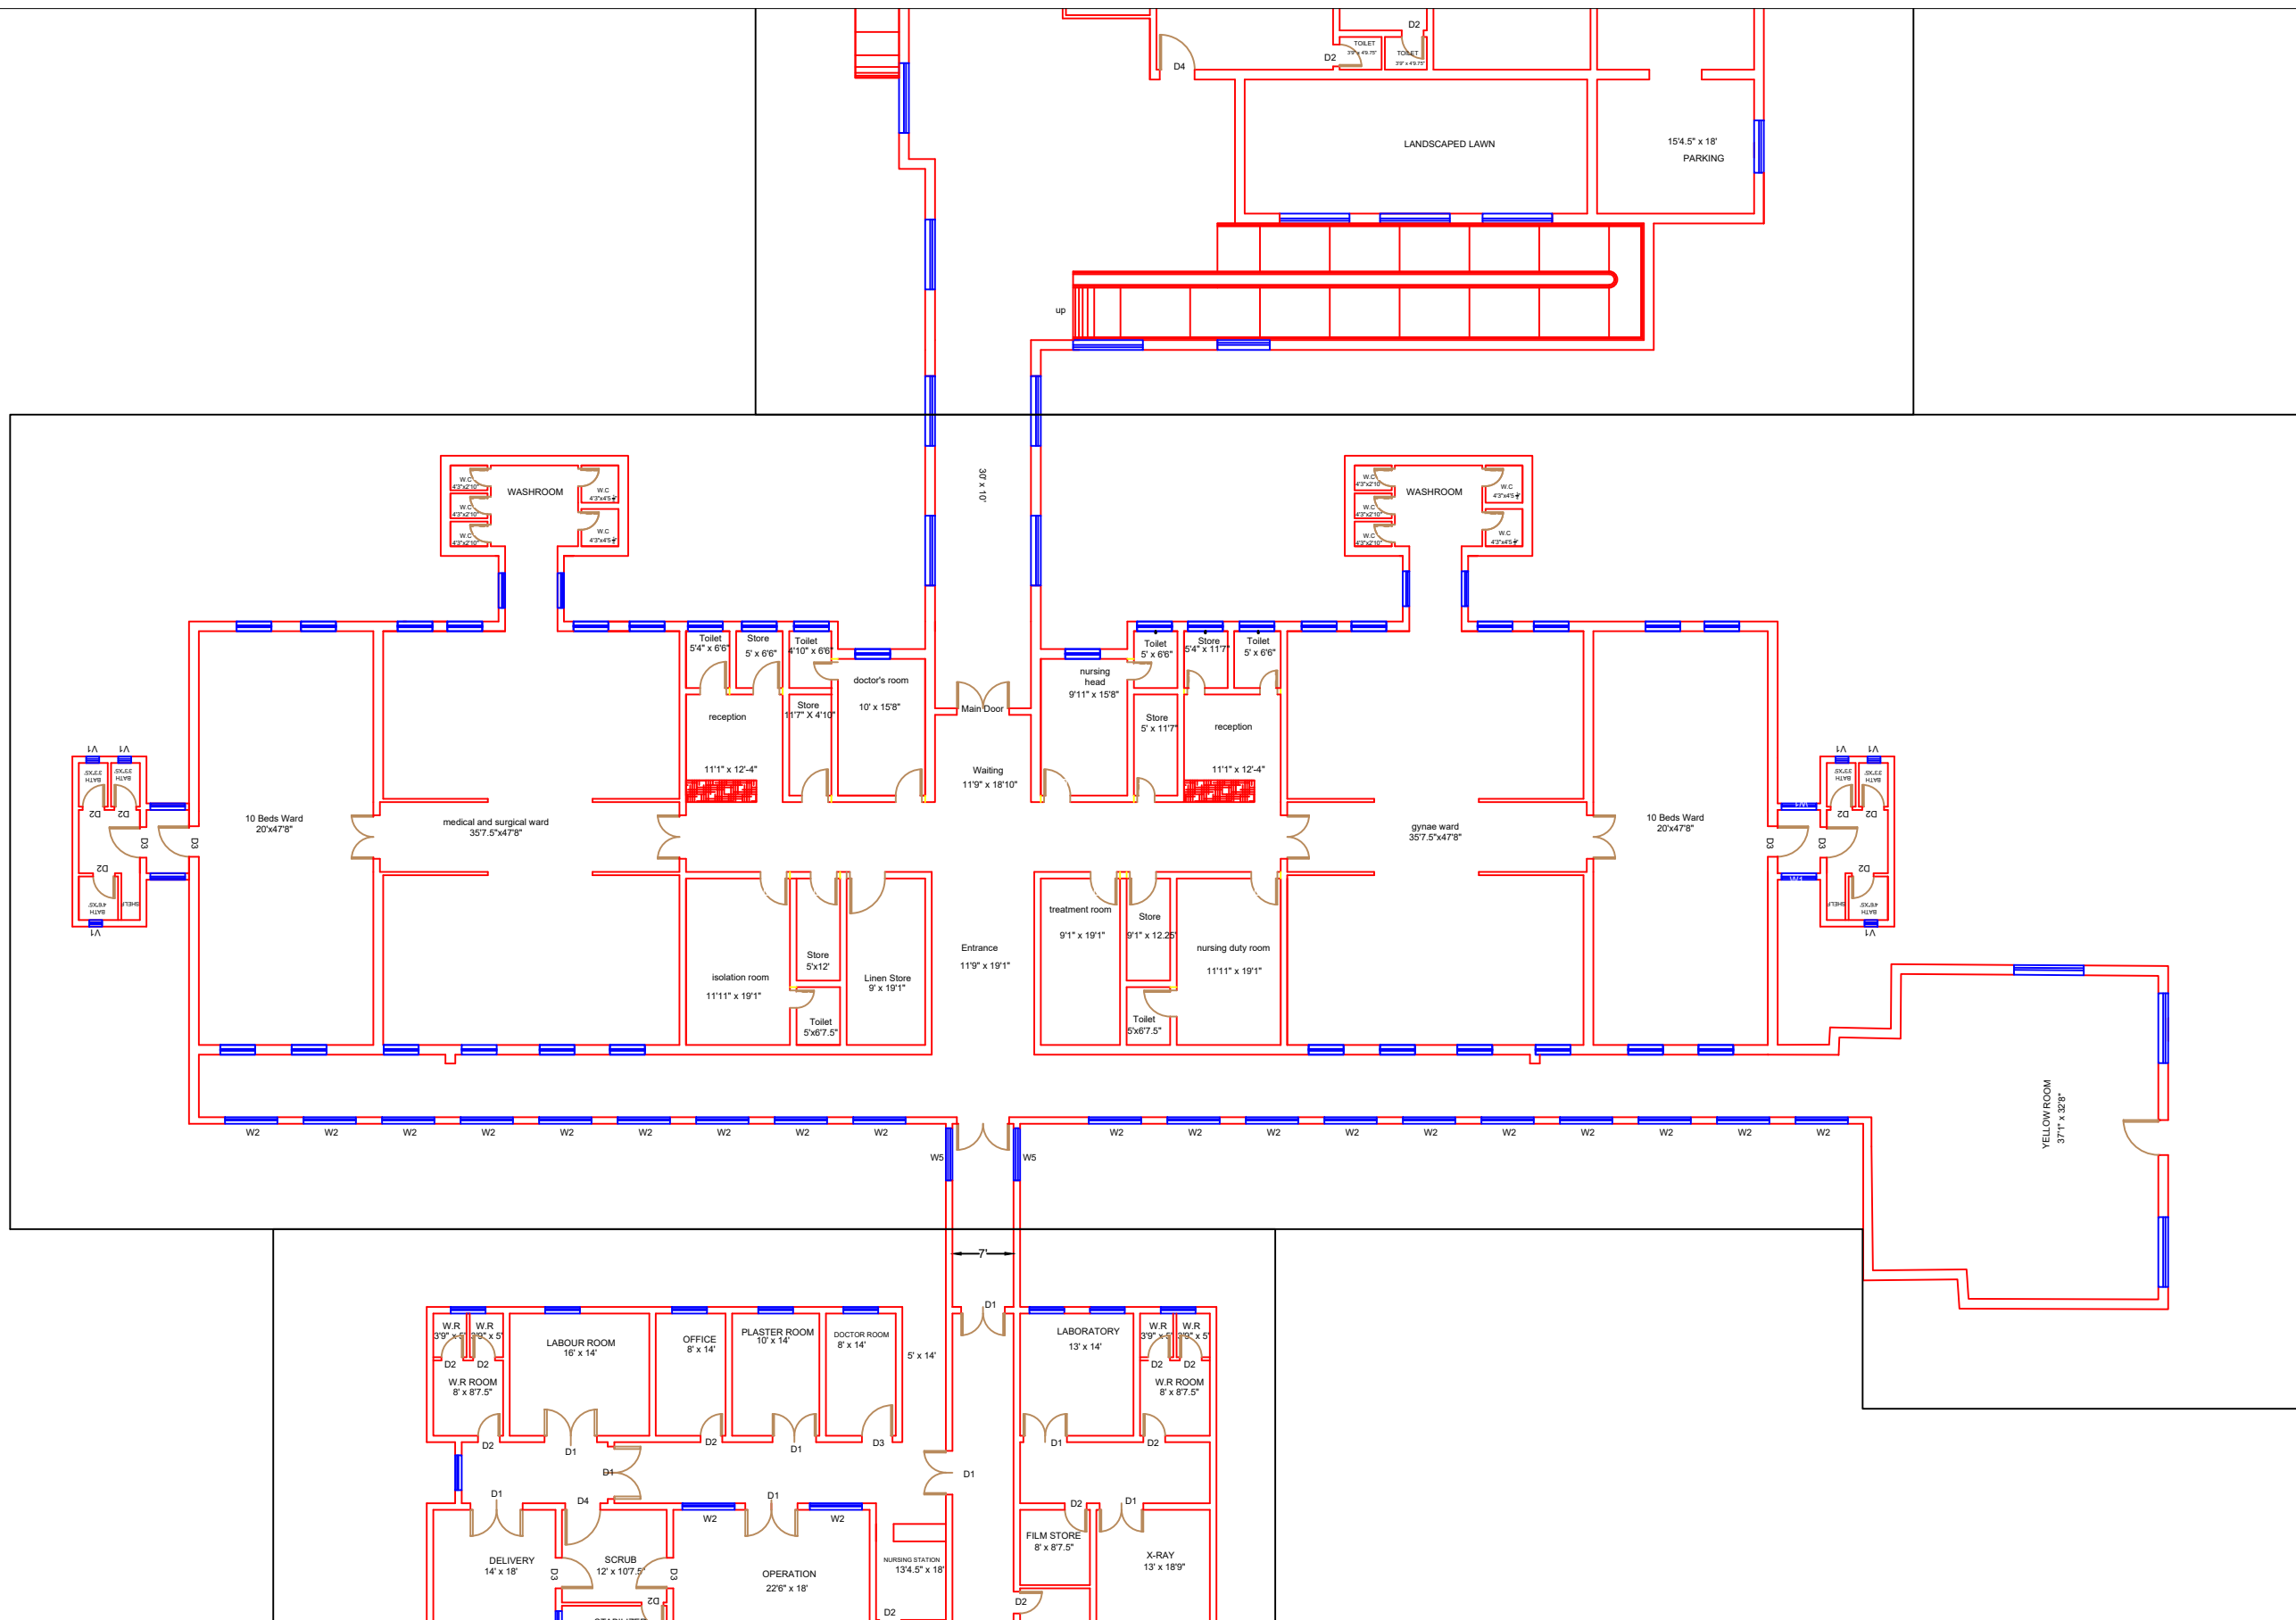  















Drawing Title: **THQ JARANWALA
CLINICAL BLOCK PLAN (PART 1)**

Drawing No.	SKAFS/JARANWALA/09
-------------	---------------------------

   CLINICAL BLOCK OF THQ HOSPITAL JARANWALA
GROUND FLOOR PART 2





Legends:

Residential Area	
Road	
Wall	
Power Line	
OHT	
Tree	
Man Hole	
Tube Well	
Light Pole	
Lawns	
Earthen Areas	
Asphalts Roads	
Tough Pavers	
P.C.C / Plinth Protection	
Boundary Wall	
Brick Pavers / Soling	
Drain	
Tap	
Hand Pump	
Air Conditioner	
Tube Light	
Fan	
Roof Light	
Bulb	

AREA	
AREA WITHIN BOUNDARY WALL	286049.88 Sft
AREA OF CLINICAL BLOCK	51250.88 Sft
PLINTH AREA OF BLOCK	39354.48 Sft

[illegible]


Project: **CAD MAPPING OF TEHSIL
HEAD QUARTER HOSPITALS,
PUNJAB**

<p>Client:</p>  <p>GOVERNMENT OF THE PUNJAB PRIMARY & SECONDARY HEALTHCARE DEPARTMENT</p>	<p>Consultant:</p>  <p>SKAFS CONSULTANT (Pvt.) Limited ENGINEERING AND ENVIRONMENT CONSULTANT.</p>
--	--









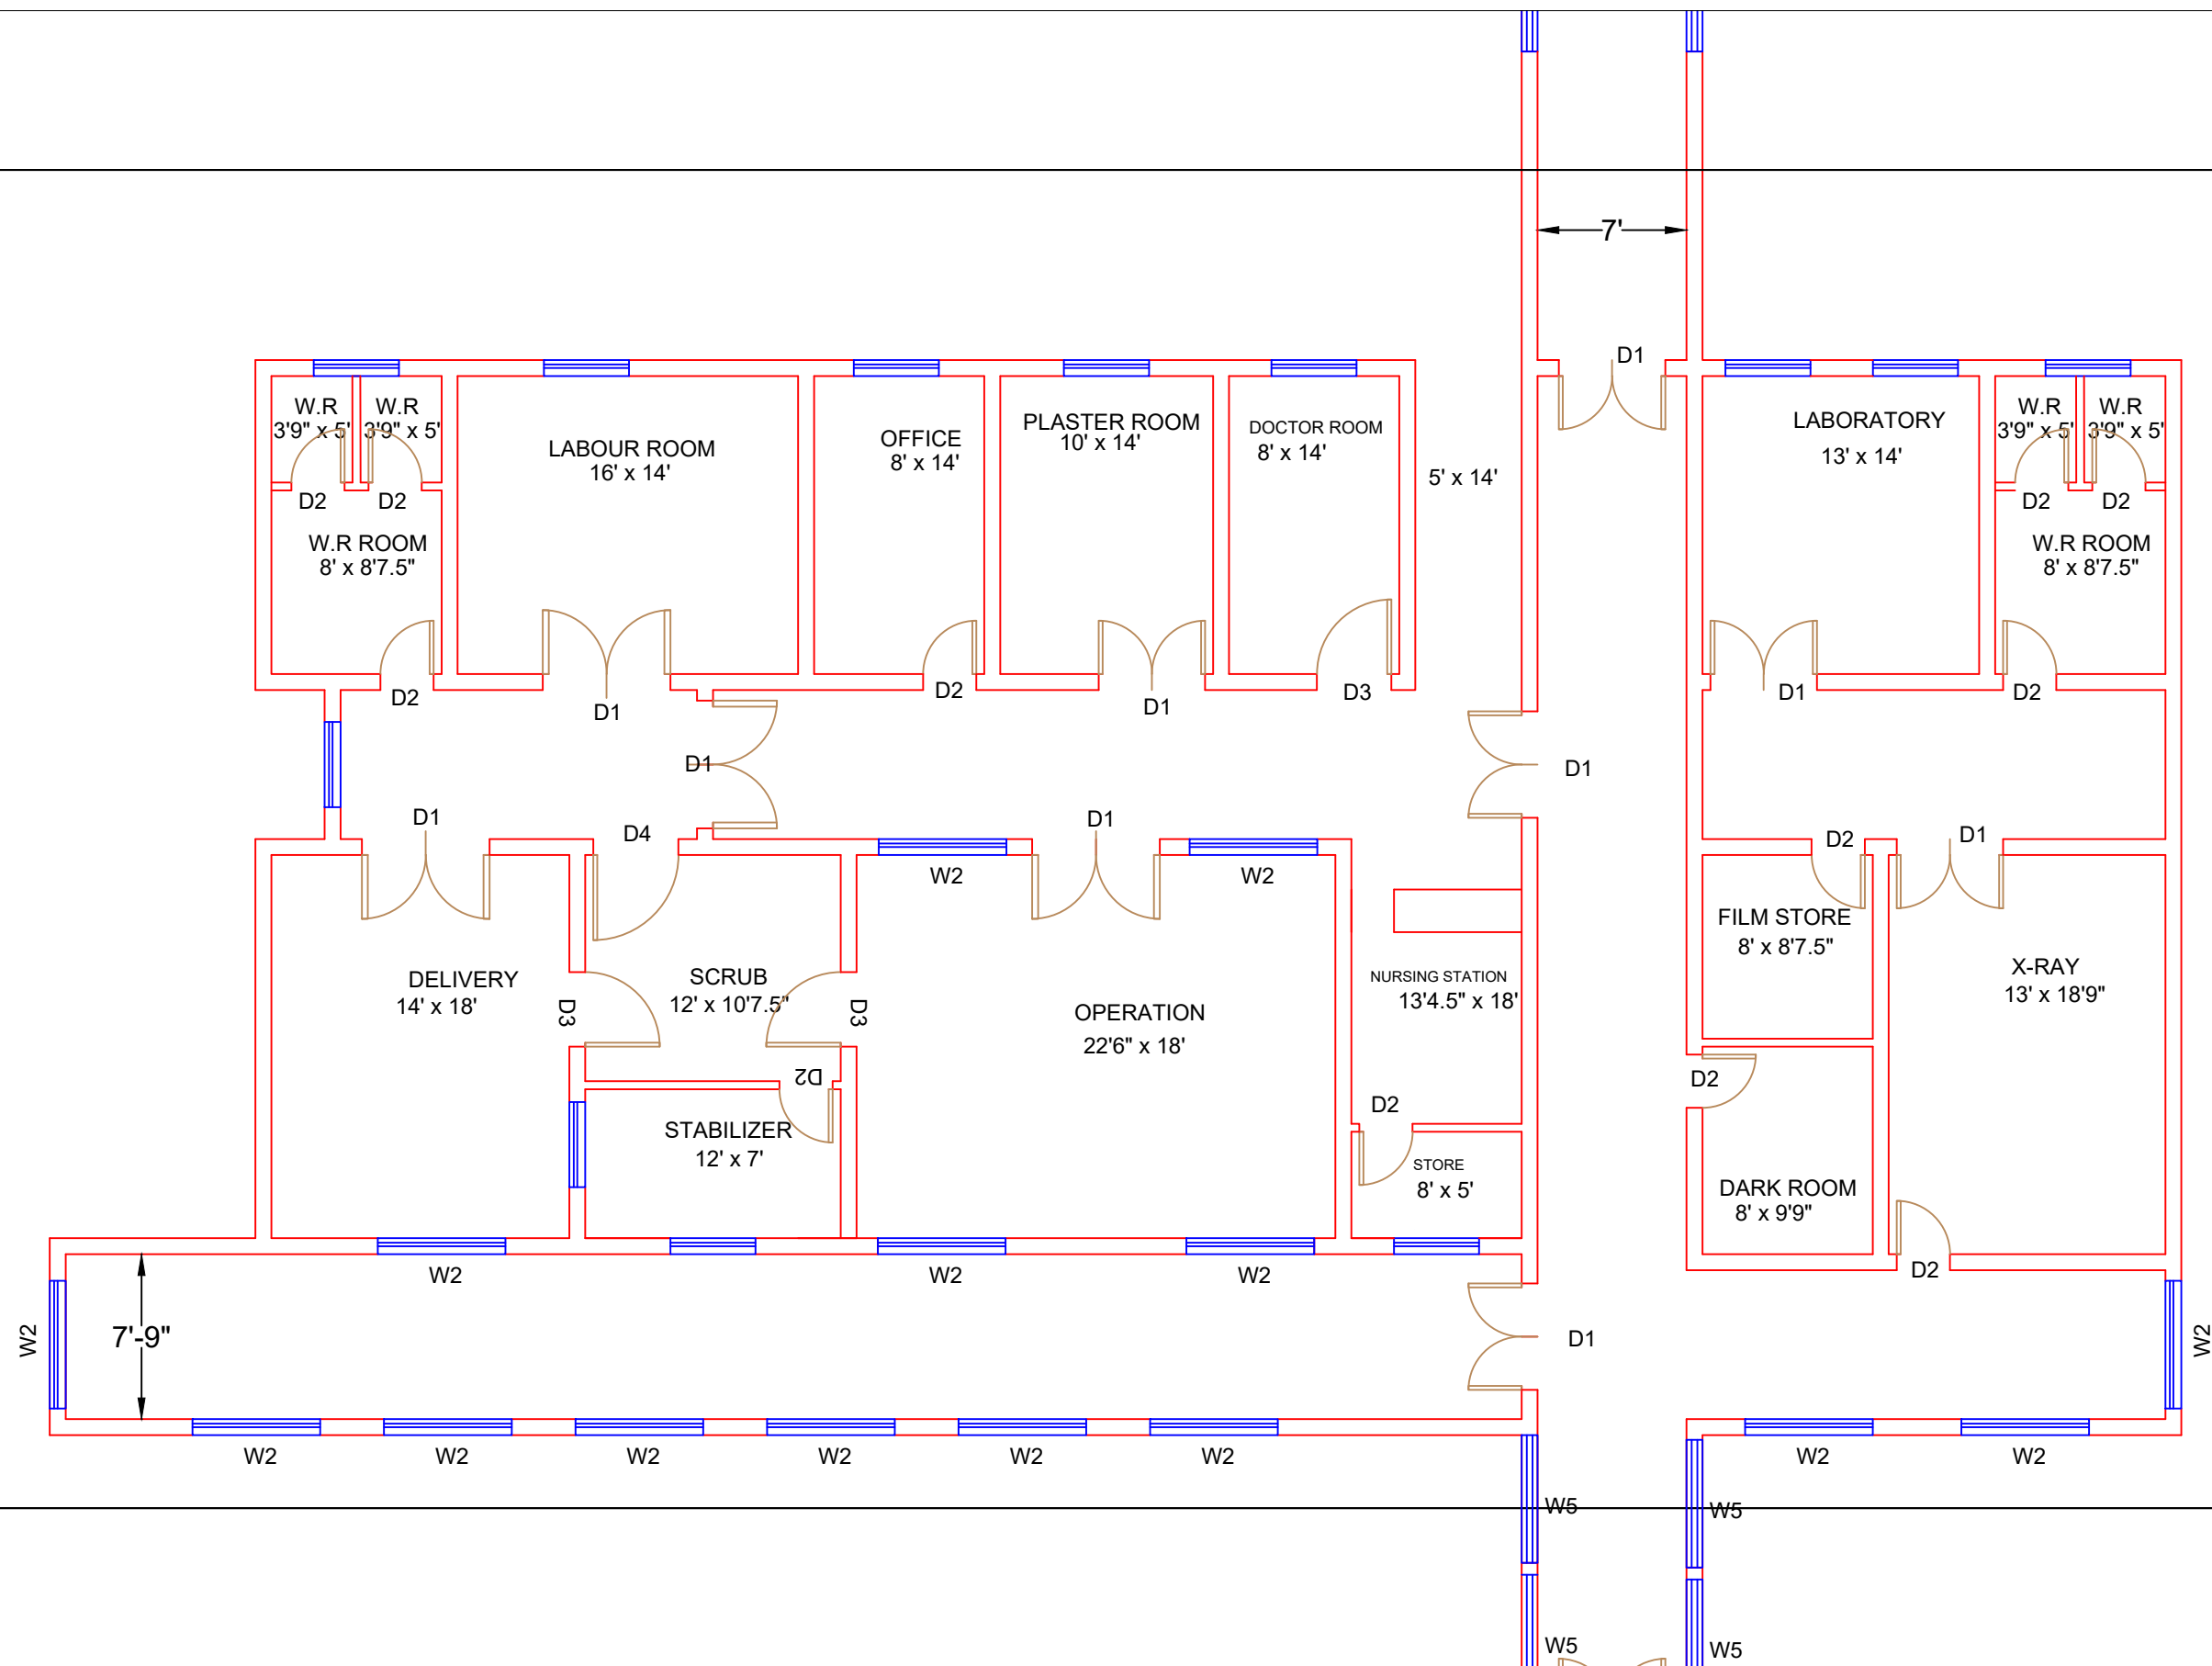  








 
 
 




Drawing Title:	THQ JARANWALA CLINICAL BLOCK PLAN (PART 2)
----------------	---

Drawing No.	SKAFS/JARANWALA/10
-------------	--------------------

CLINICAL BLOCK OF THQ HOSPITAL JARANWALA
GROUND FLOOR PART 3




 
Legends:

Residential Area	
Road	
Wall	
Power Line	
OHT	
Tree	
Man Hole	
Tube Well	
Light Pole	
Lawns	
Earthen Areas	
Asphalts Roads	
Tough Pavers	
P.C.C / Plinth Protection	
Boundary Wall	
Brick Pavers / Soling	
Drain	
Tap	
Hand Pump	
Air Conditioner	
Tube Light	
Fan	
Roof Light	
Bulb	

AREA	
AREA WITHIN BOUNDARY WALL	286049.88 Sft
AREA OF CLINICAL BLOCK	51250.88 Sft
PLINTH AREA OF BLOCK	39354.48 Sft

OPENING SCHEDULE OF DOORS AND WINDOWS					
DOORS	WIDTH	HEIGHT	WINDOWS	WIDTH	HEIGHT
D1	5'-0"	7'-0"	W1	4'-0"	4'-0"
D2	2'-6"	7'-0"	W2	6'-0"	6'-0"
D3	3'-6"	7'-0"	W3	8'-0"	8'-0"
D4	4'-0"	7'-0"	V1	1'-6"	1'-6"

Project:
**CAD MAPPING OF TEHSIL
HEAD QUARTER HOSPITALS,
PUNJAB**


<p>Client:</p>  <p>GOVERNMENT OF THE PUNJAB PRIMARY & SECONDARY HEALTHCARE DEPARTMENT</p>	<p>Consultant:</p>  <p>SKAFS CONSULTANT (Pvt.) Limited <i>ENGINEERING AND ENVIRONMENT CONSULTANT</i></p>
--	--

Drawing Title: **THQ JARANWALA
CLINICAL BLOCK PLAN (PART 3)**

Drawing No.	SKAFS/JARANWALA/11
-------------	---------------------------

CLINICAL BLOCK OF THQ HOSPITAL JARANWALA

GROUND FLOOR PART 4

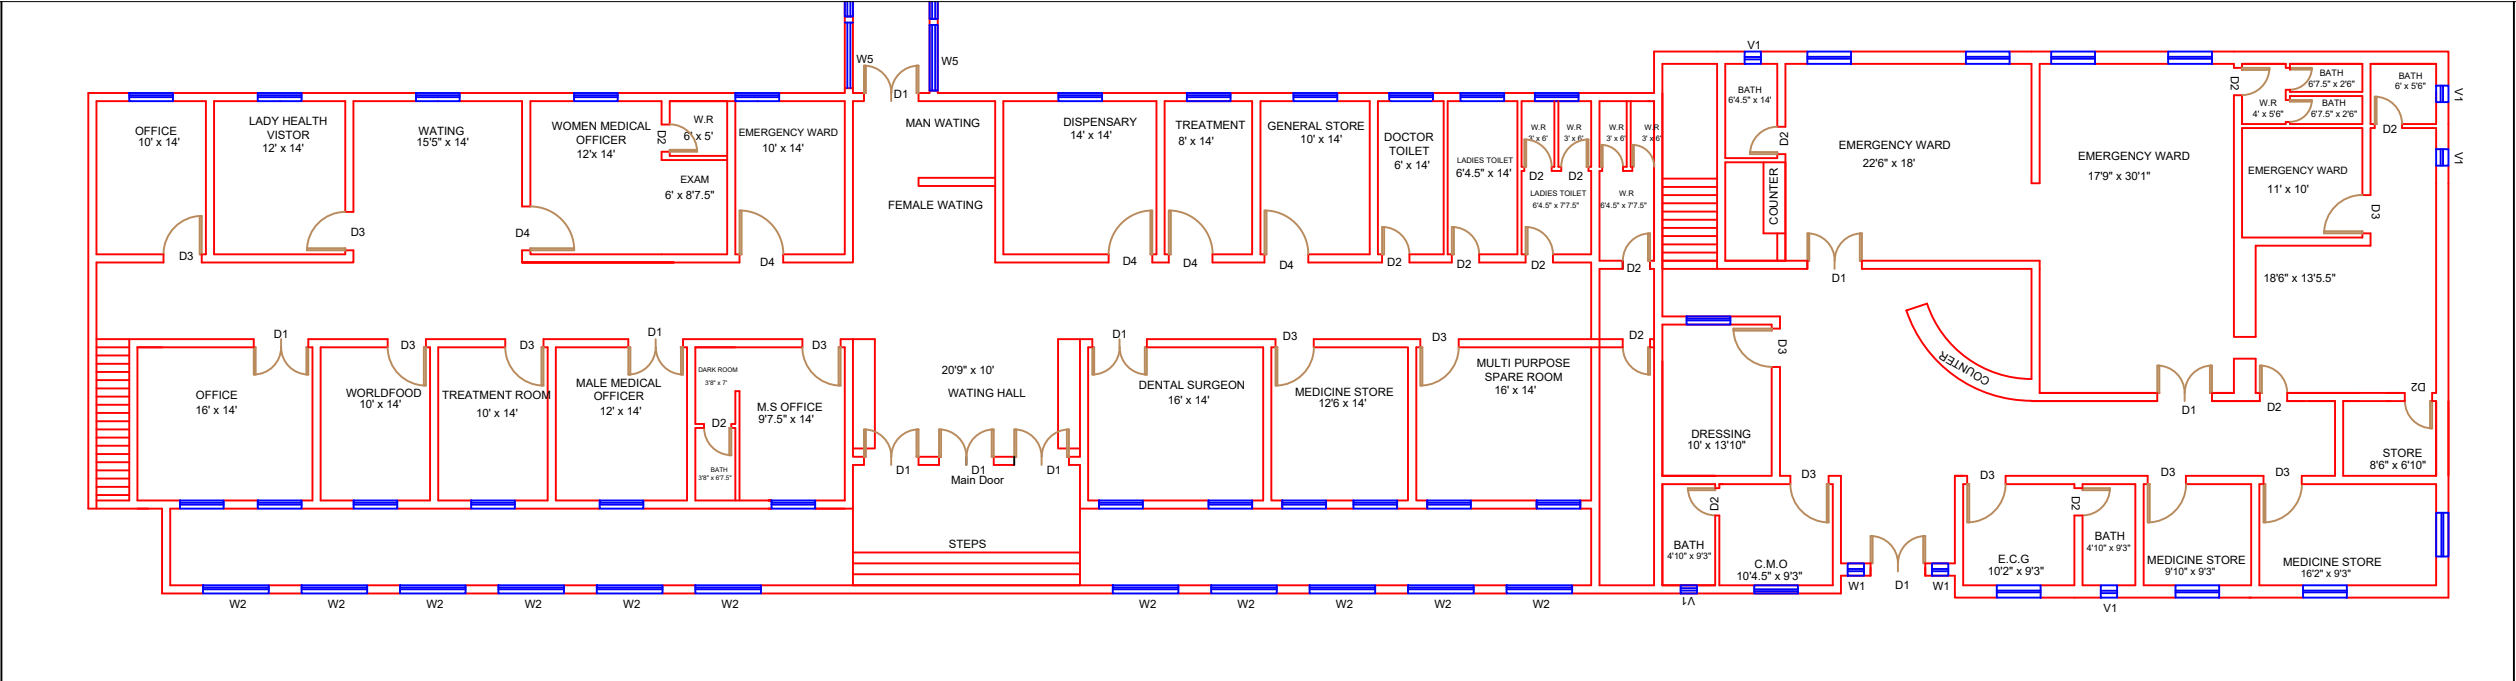

Legends:

Residential Area	
Road	
Wall	
Power Line	
OHT	
Tree	
Man Hole	
Tube Well	
Light Pole	
Lawns	
Earthen Areas	
Asphalts Roads	
Tough Pavers	
P.C.C / Plinth Protection	
Boundary Wall	
Brick Pavers / Soling	
Drain	
Tap	
Hand Pump	
Air Conditioner	
Tube Light	
Fan	
Roof Light	
Bulb	

AREA

AREA WITHIN BOUNDARY WALL	286049.88 Sft
AREA OF CLINICAL BLOCK	51250.88 Sft
PLINTH AREA OF BLOCK	39354.48 Sft

OPENING SCHEDULE OF DOORS AND WINDOWS

DOORS	WIDTH	HEIGHT	WINDOWS	WIDTH	HEIGHT
D1	5'-0"	7'-0"	W1	4'-0"	4'-0"
D2	2'-6"	7'-0"	W2	6'-0"	6'-0"
D3	3'-6"	7'-0"	W3	8'-0"	8'-0"
D4	4'-0"	7'-0"	V1	1'-6"	1'-6"


Project:
**CAD MAPPING OF TEHSIL
HEAD QUARTER HOSPITALS,
PUNJAB**

Client: GOVERNMENT OF THE PUNJAB PRIMARY & SECONDARY HEALTHCARE DEPARTMENT	Consultant: SKAFS CONSULTANT (Pvt.) Limited ENGINEERING AND ENVIRONMENT CONSULTANT
---	--







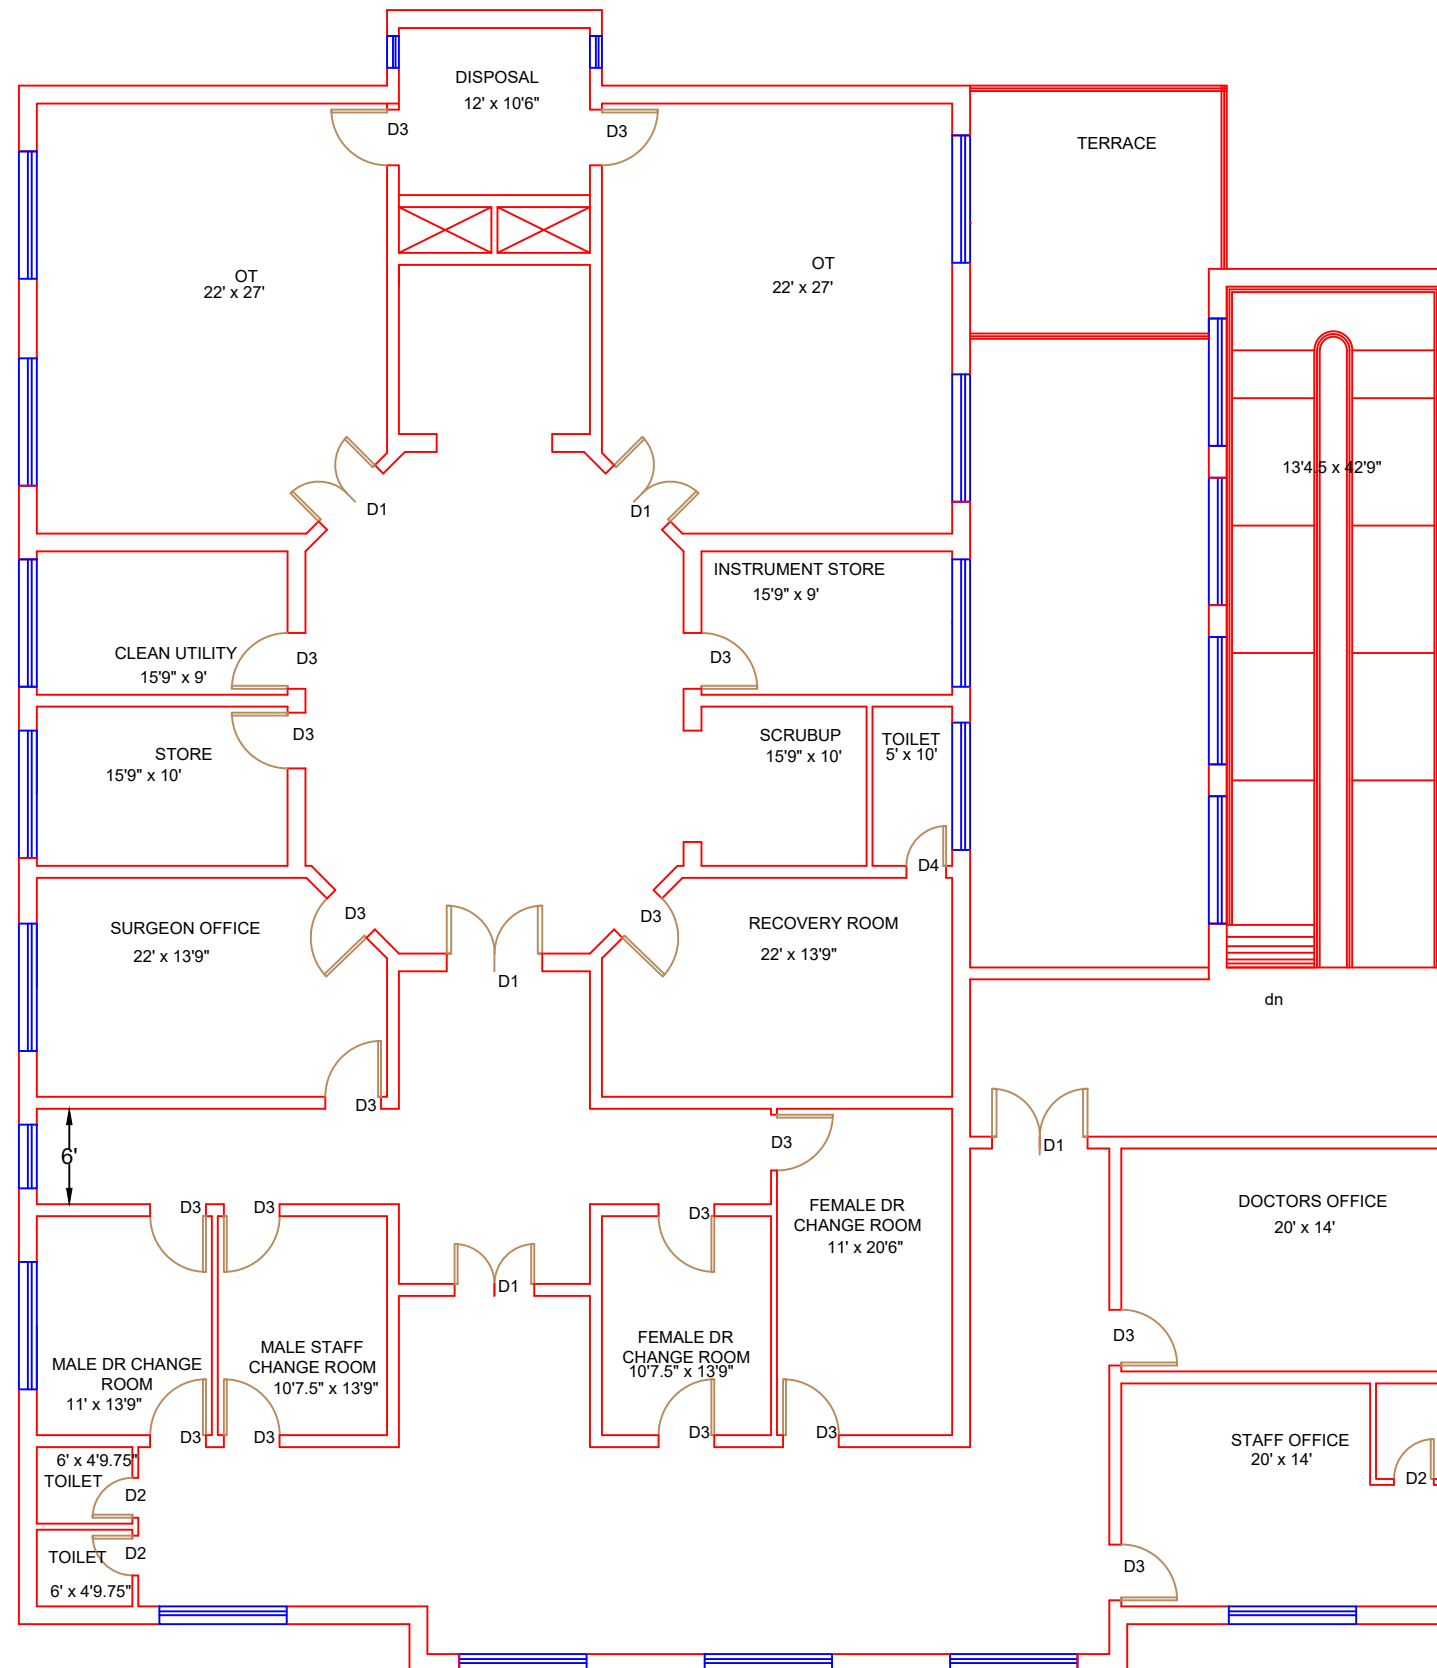










 






Drawing Title:
**THQ JARANWALA
CLINICAL BLOCK PLAN (PART 4)**

Drawing No.
SKAFS/JARANWALA/12

CLINICAL BLOCK OF THQ HOSPITAL JARANWALA
FIRST FLOOR PART 1





Legends:

Residential Area	
Road	
Wall	
Power Line	
OHT	
Tree	
Man Hole	
Tube Well	
Light Pole	
Lawns	
Earthen Areas	
Asphalts Roads	
Tough Pavers	
P.C.C / Plinth Protection	
Boundary Wall	
Brick Pavers / Soling	
Drain	
Tap	
Hand Pump	
Air Conditioner	
Tube Light	
Fan	
Roof Light	
Bulb	

AREA	
AREA WITHIN BOUNDARY WALL	286049.88 Sft
AREA OF CLINICAL BLOCK	51250.88 Sft
PLINTH AREA OF BLOCK	39354.48 Sft

[illegible]

Project:
**CAD MAPPING OF TEHSIL
HEAD QUARTER HOSPITALS,
PUNJAB**


<p>Client:</p>  <p>GOVERNMENT OF THE PUNJAB PRIMARY & SECONDARY HEALTHCARE DEPARTMENT</p>	<p>Consultant:</p>  <p>SKAFS CONSULTANT (Pvt.) Limited <i>ENGINEERING AND ENVIRONMENT</i></p>
--	--

Drawing Title: THQ JARANWALA FIRST FLOOR PLAN (PART 1)	
---	--

Drawing No. **SKAFS/JARANWALA/13**

CLINICAL BLOCK OF THQ HOSPITAL JARANWALA

FIRST FLOOR PART 2

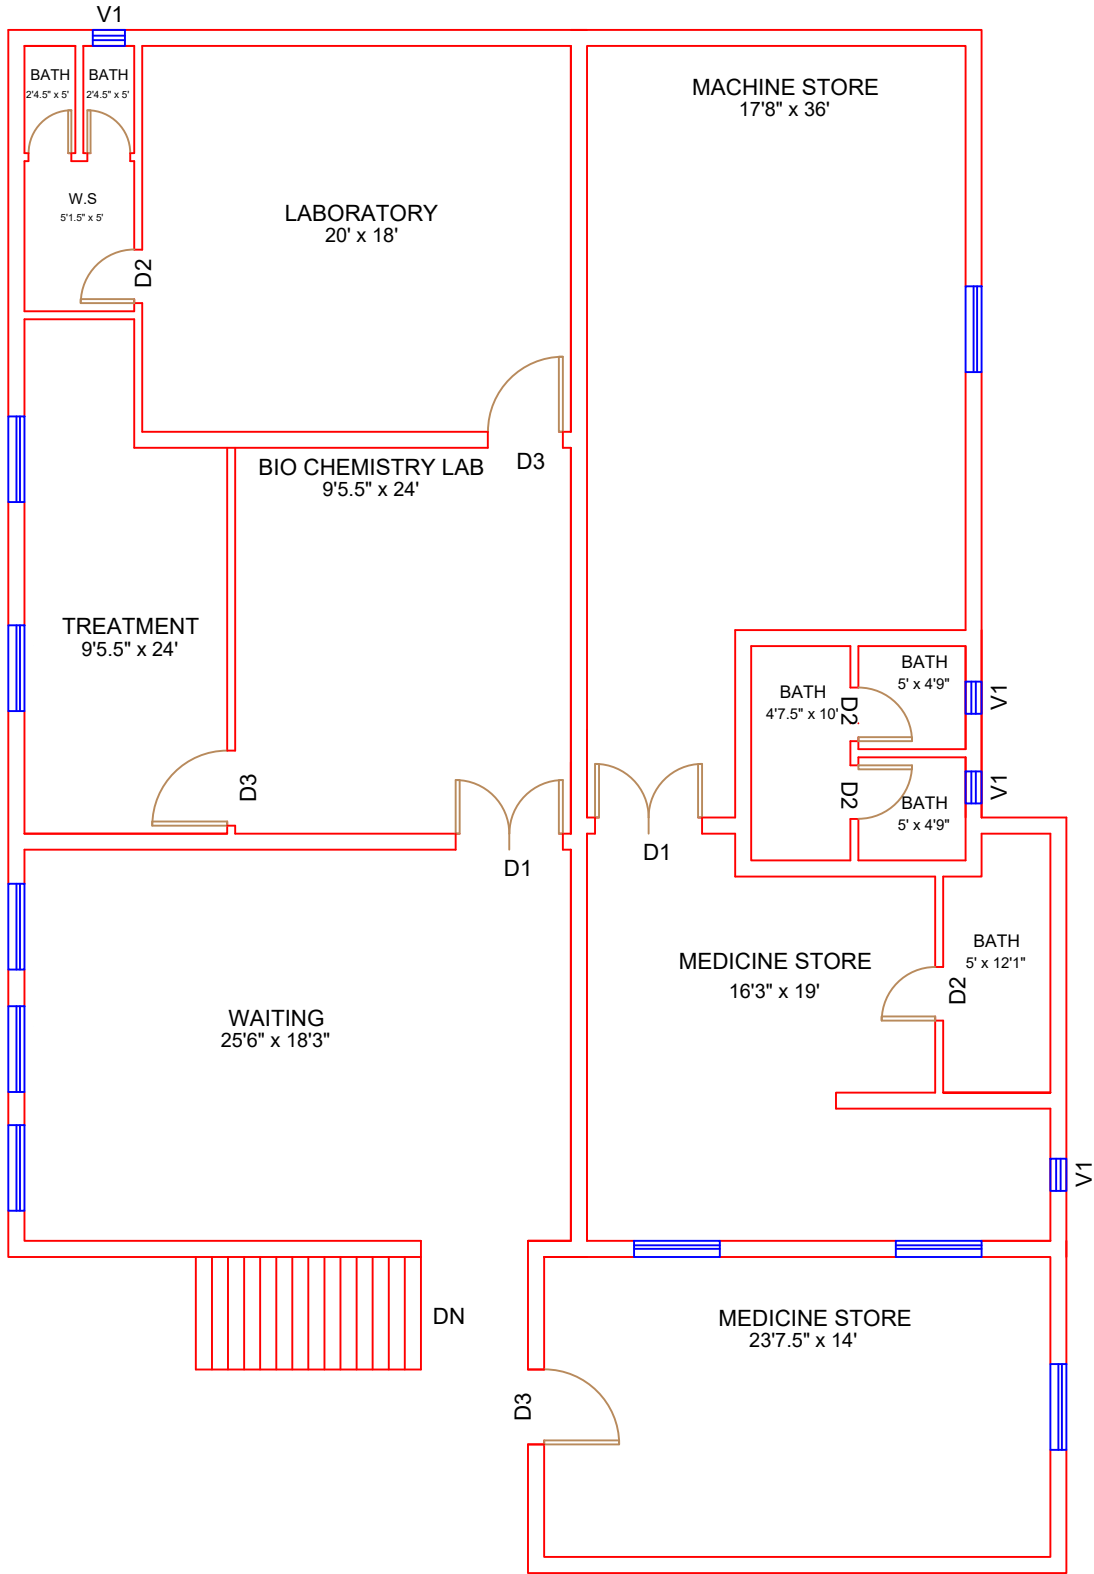

FIRST FLOOR

Legends:

Residential Area	
Road	
Wall	
Power Line	
OHT	
Tree	
Man Hole	
Tube Well	
Light Pole	
Lawns	
Earthen Areas	
Asphalts Roads	
Tough Pavers	
P.C.C / Plinth Protection	
Boundary Wall	
Brick Pavers / Soling	
Drain	
Tap	
Hand Pump	
Air Conditioner	
Tube Light	
Fan	
Roof Light	
Bulb	

AREA	
AREA WITHIN BOUNDARY WALL	286049.88 Sft
AREA OF CLINICAL BLOCK	51250.88 Sft
PLINTH AREA OF BLOCK	39354.48 Sft

OPENING SCHEDULE OF DOORS AND WINDOWS					
DOORS	WIDTH	HEIGHT	WINDOWS	WIDTH	HEIGHT
D1	5'-0"	7'-0"	W1	4'-0"	4'-0"
D2	2'-6"	7'-0"	W2	6'-0"	6'-0"
D3	3'-6"	7'-0"	W3	8'-0"	8'-0"
D4	4'-0"	7'-0"	V1	1'-6"	1'-6"

Project:
**CAD MAPPING OF TEHSIL
HEAD QUARTER HOSPITALS,
PUNJAB**

Client:

GOVERNMENT OF THE PUNJAB
PRIMARY & SECONDARY
HEALTHCARE DEPARTMENT


Consultant:

SKAFS CONSULTANT (Pvt.)
Limited
ENGINEERING AND ENVIRONMENT
CONSULTANT



 




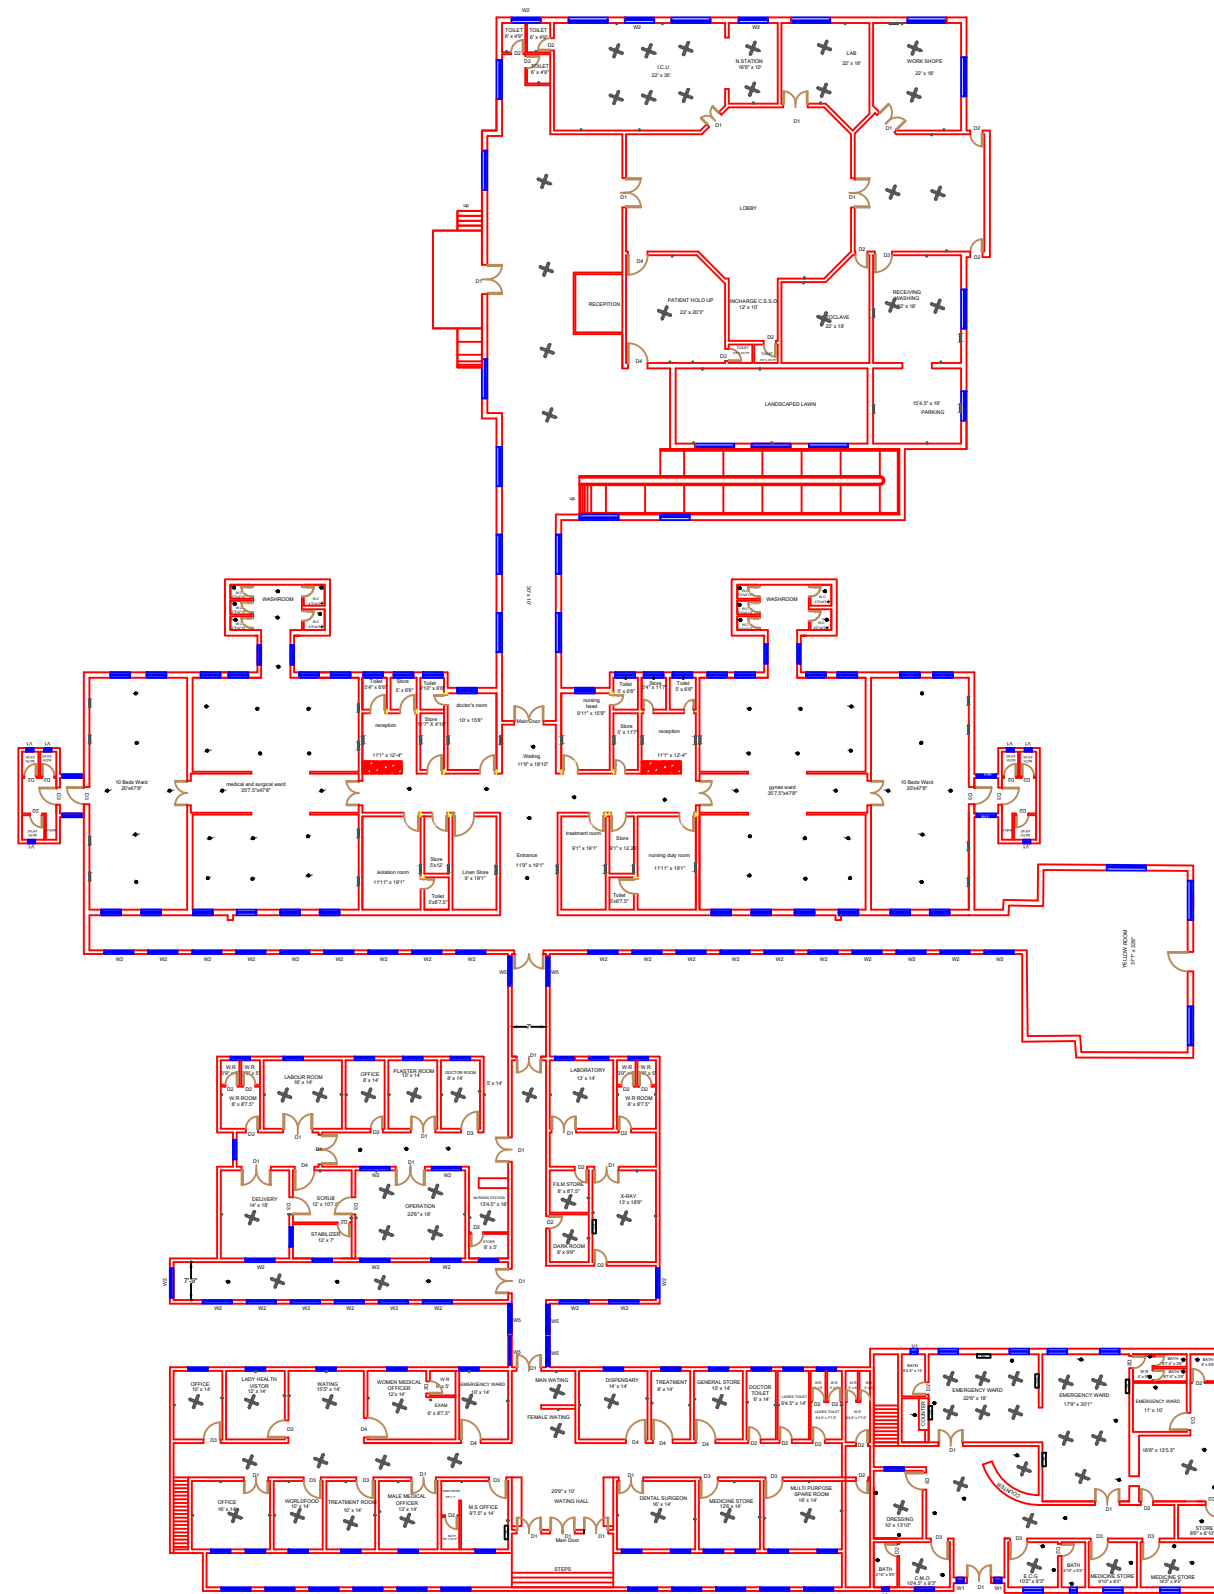
















Drawing Title:
**THQ JARANWALA
FIRST FLOOR PLAN (PART 2)**

Drawing No.
SKAFS/JARANWALA/14

ELECTRICAL LAYOUT PLAN OF THQ HOSPITAL JARANWALA GROUND FLOOR





Legends:

Residential Area	
Road	
Wall	
Power Line	
OHT	
Tree	
Man Hole	
Tube Well	
Light Pole	
Lawns	
Earthen Areas	
Asphalts Roads	
Tough Pavers	
P.C.C / Plinth Protection	
Boundary Wall	
Brick Pavers / Soling	
Drain	
Tap	
Hand Pump	
Air Conditioner	
Tube Light	
Fan	
Roof Light	
Bulb	

AREA	
AREA WITHIN BOUNDARY WALL	286049.88 Sft
AREA OF CLINICAL BLOCK	51250.88 Sft
PLINTH AREA OF BLOCK	39354.48 Sft

[illegible]


Project:
**CAD MAPPING OF TEHSIL
HEAD QUARTER HOSPITALS,
PUNJAB**

<p>Client:</p>  <p>GOVERNMENT OF THE PUNJAB PRIMARY & SECONDARY HEALTHCARE DEPARTMENT</p>	<p>Consultant:</p>  <p>SKAFS CONSULTANT (Pvt.) Limited <i>ENGINEERING AND ENVIRONMENT CONSULTANT</i></p>
--	---


Drawing Title: **THQ JARANWALA
ELECTRICAL PLAN (GROUND FLOOR)**

Drawing No. **SKAFS/JARANWALA/15**

 
 


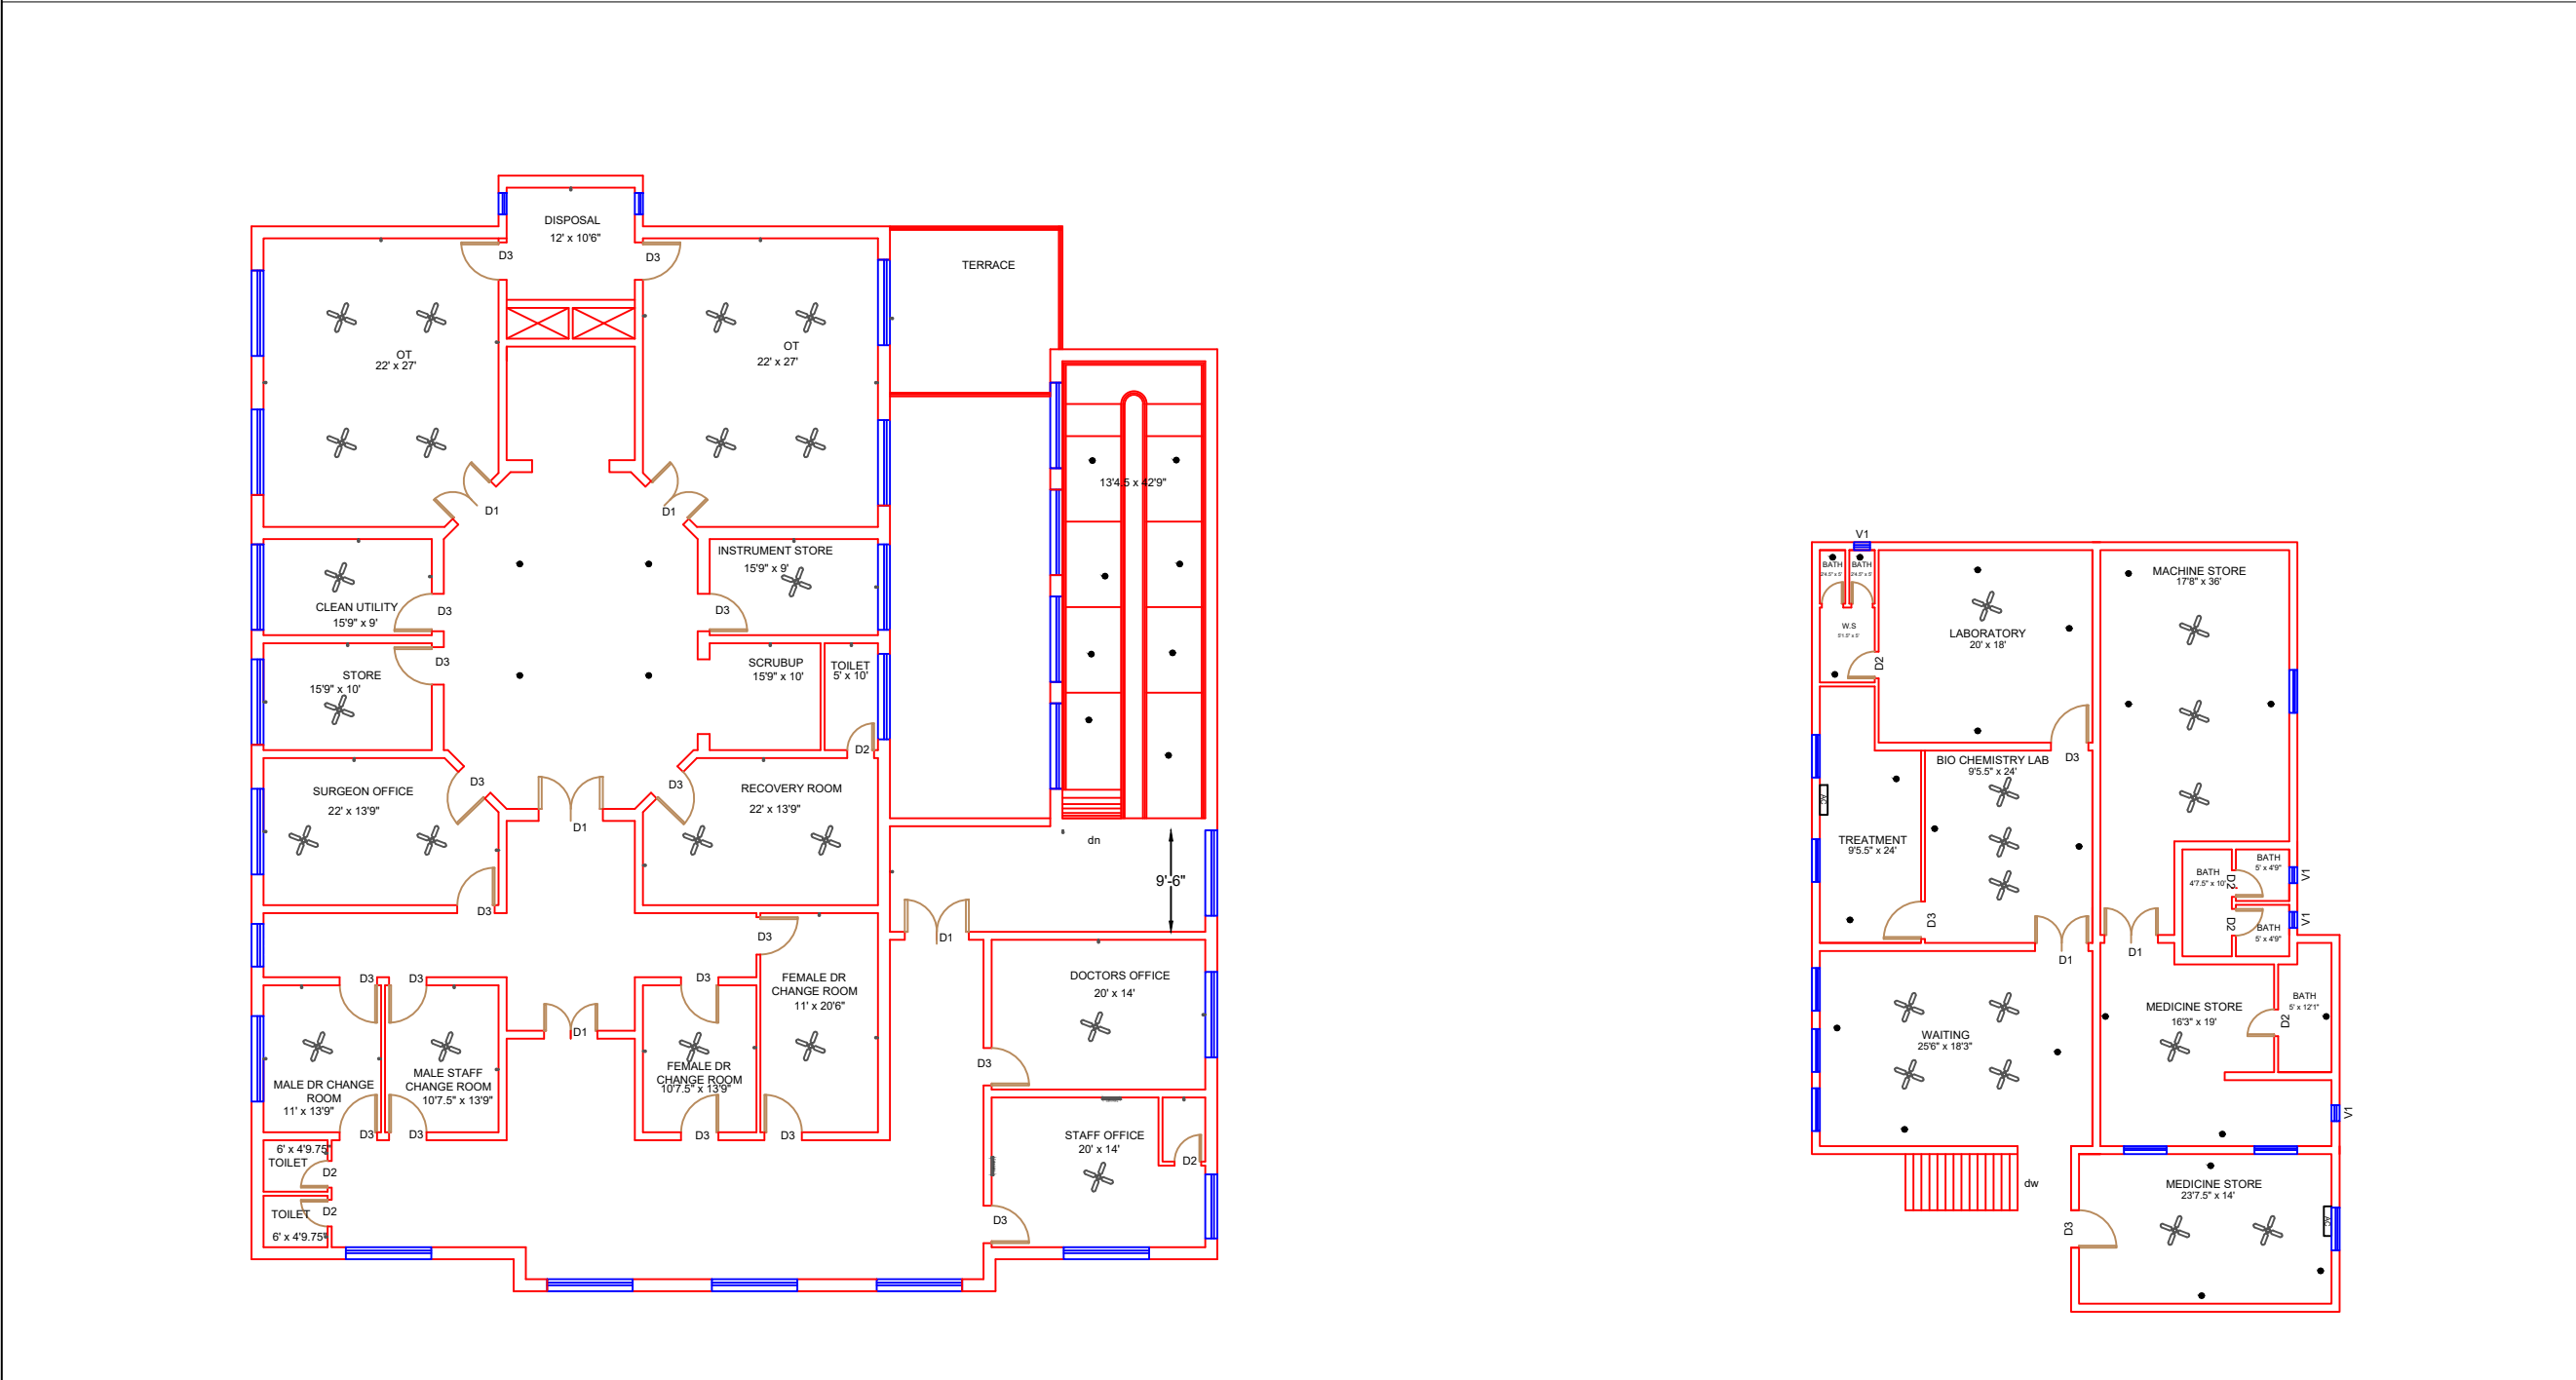



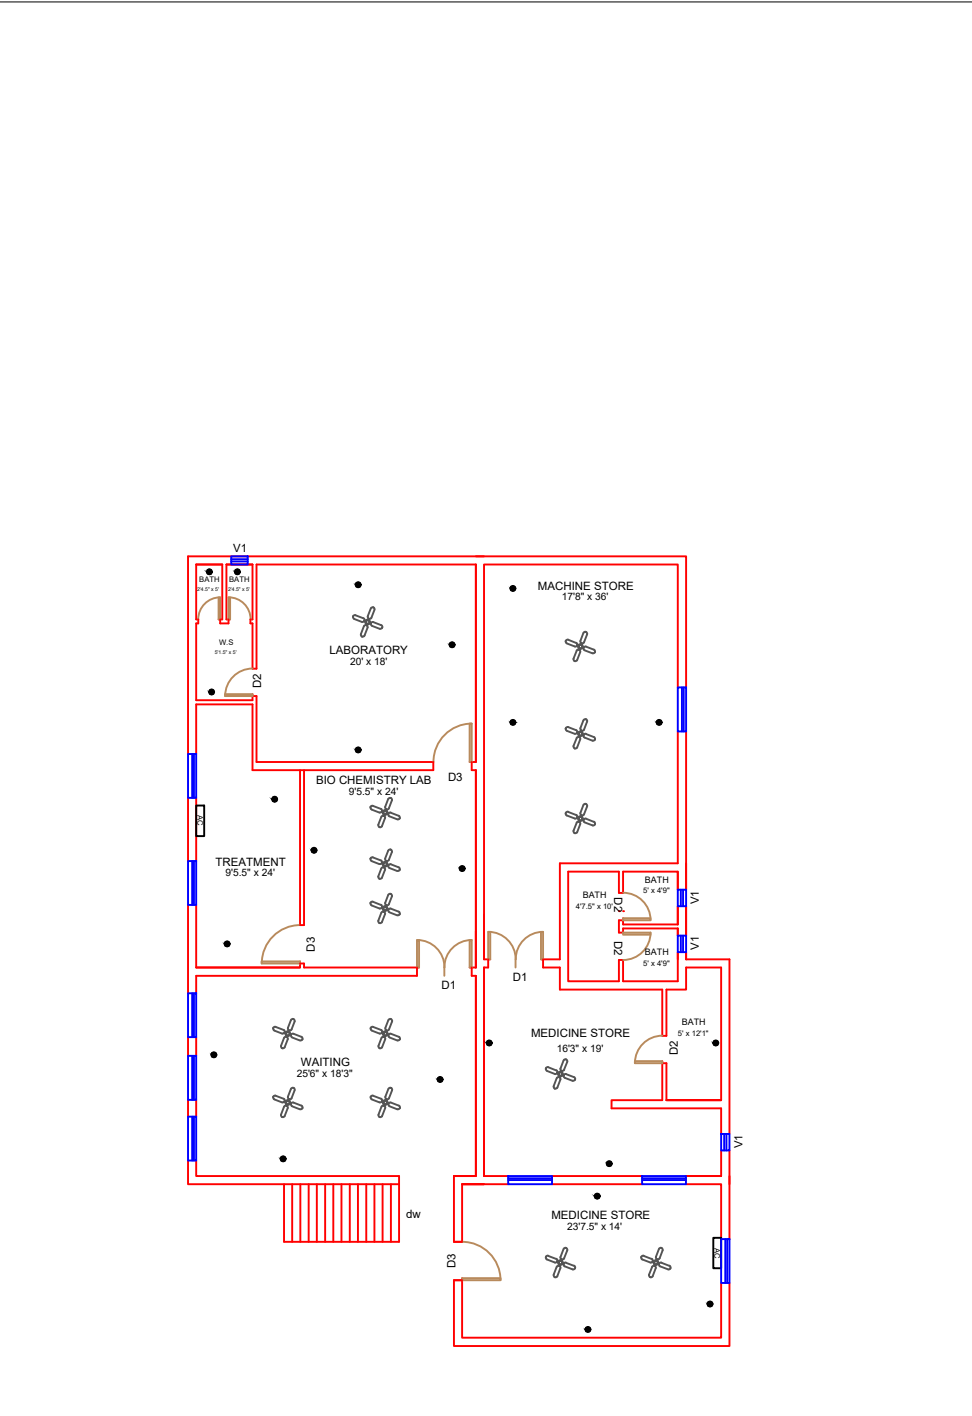




 



 







ELECTRICAL LAYOUT PLAN OF THQ HOSPITAL JARANWALA FIRST FLOOR



 FIRST FLOOR





Legends:

Residential Area	
Road	
Wall	
Power Line	
OHT	
Tree	
Man Hole	
Tube Well	
Light Pole	
Lawns	
Earthen Areas	
Asphalts Roads	
Tough Pavers	
P.C.C / Plinth Protection	
Boundary Wall	
Brick Pavers / Soling	
Drain	
Tap	
Hand Pump	 H.P. 
Air Conditioner	
Tube Light	
Fan	
Roof Light	
Bulb	

AREA	
AREA WITHIN BOUNDARY WALL	286049.88 Sft
AREA OF CLINICAL BLOCK	51250.88 Sft
PLINTH AREA OF BLOCK	39354.48 Sft

[illegible]

Project: CAD MAPPING OF TEHSIL HEAD QUARTER HOSPITALS, PUNJAB

<p>Client:</p>  <p>GOVERNMENT OF THE PUNJAB PRIMARY & SECONDARY HEALTHCARE DEPARTMENT</p>	<p>Consultant:</p>  <p>SKAFS CONSULTANT (Pvt.) Limited <i>ENGINEERING AND ENVIRONMENT CONSULTANT</i></p>
--	--

Drawing Title:	THQ JARANWALA ELECTRICAL PLAN (FIRST FLOOR)
----------------	--

Drawing No.	SKAFS/JARANWALA/16
-------------	---------------------------