



MASTER PLAN OF THQ HOSPITAL JHUMRA

PART 1

PART 2

PART 3

PART 4

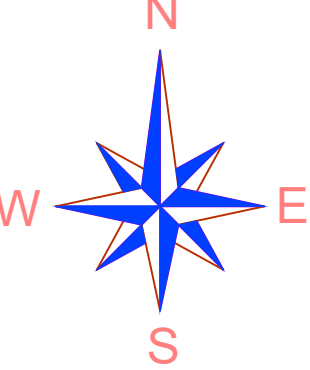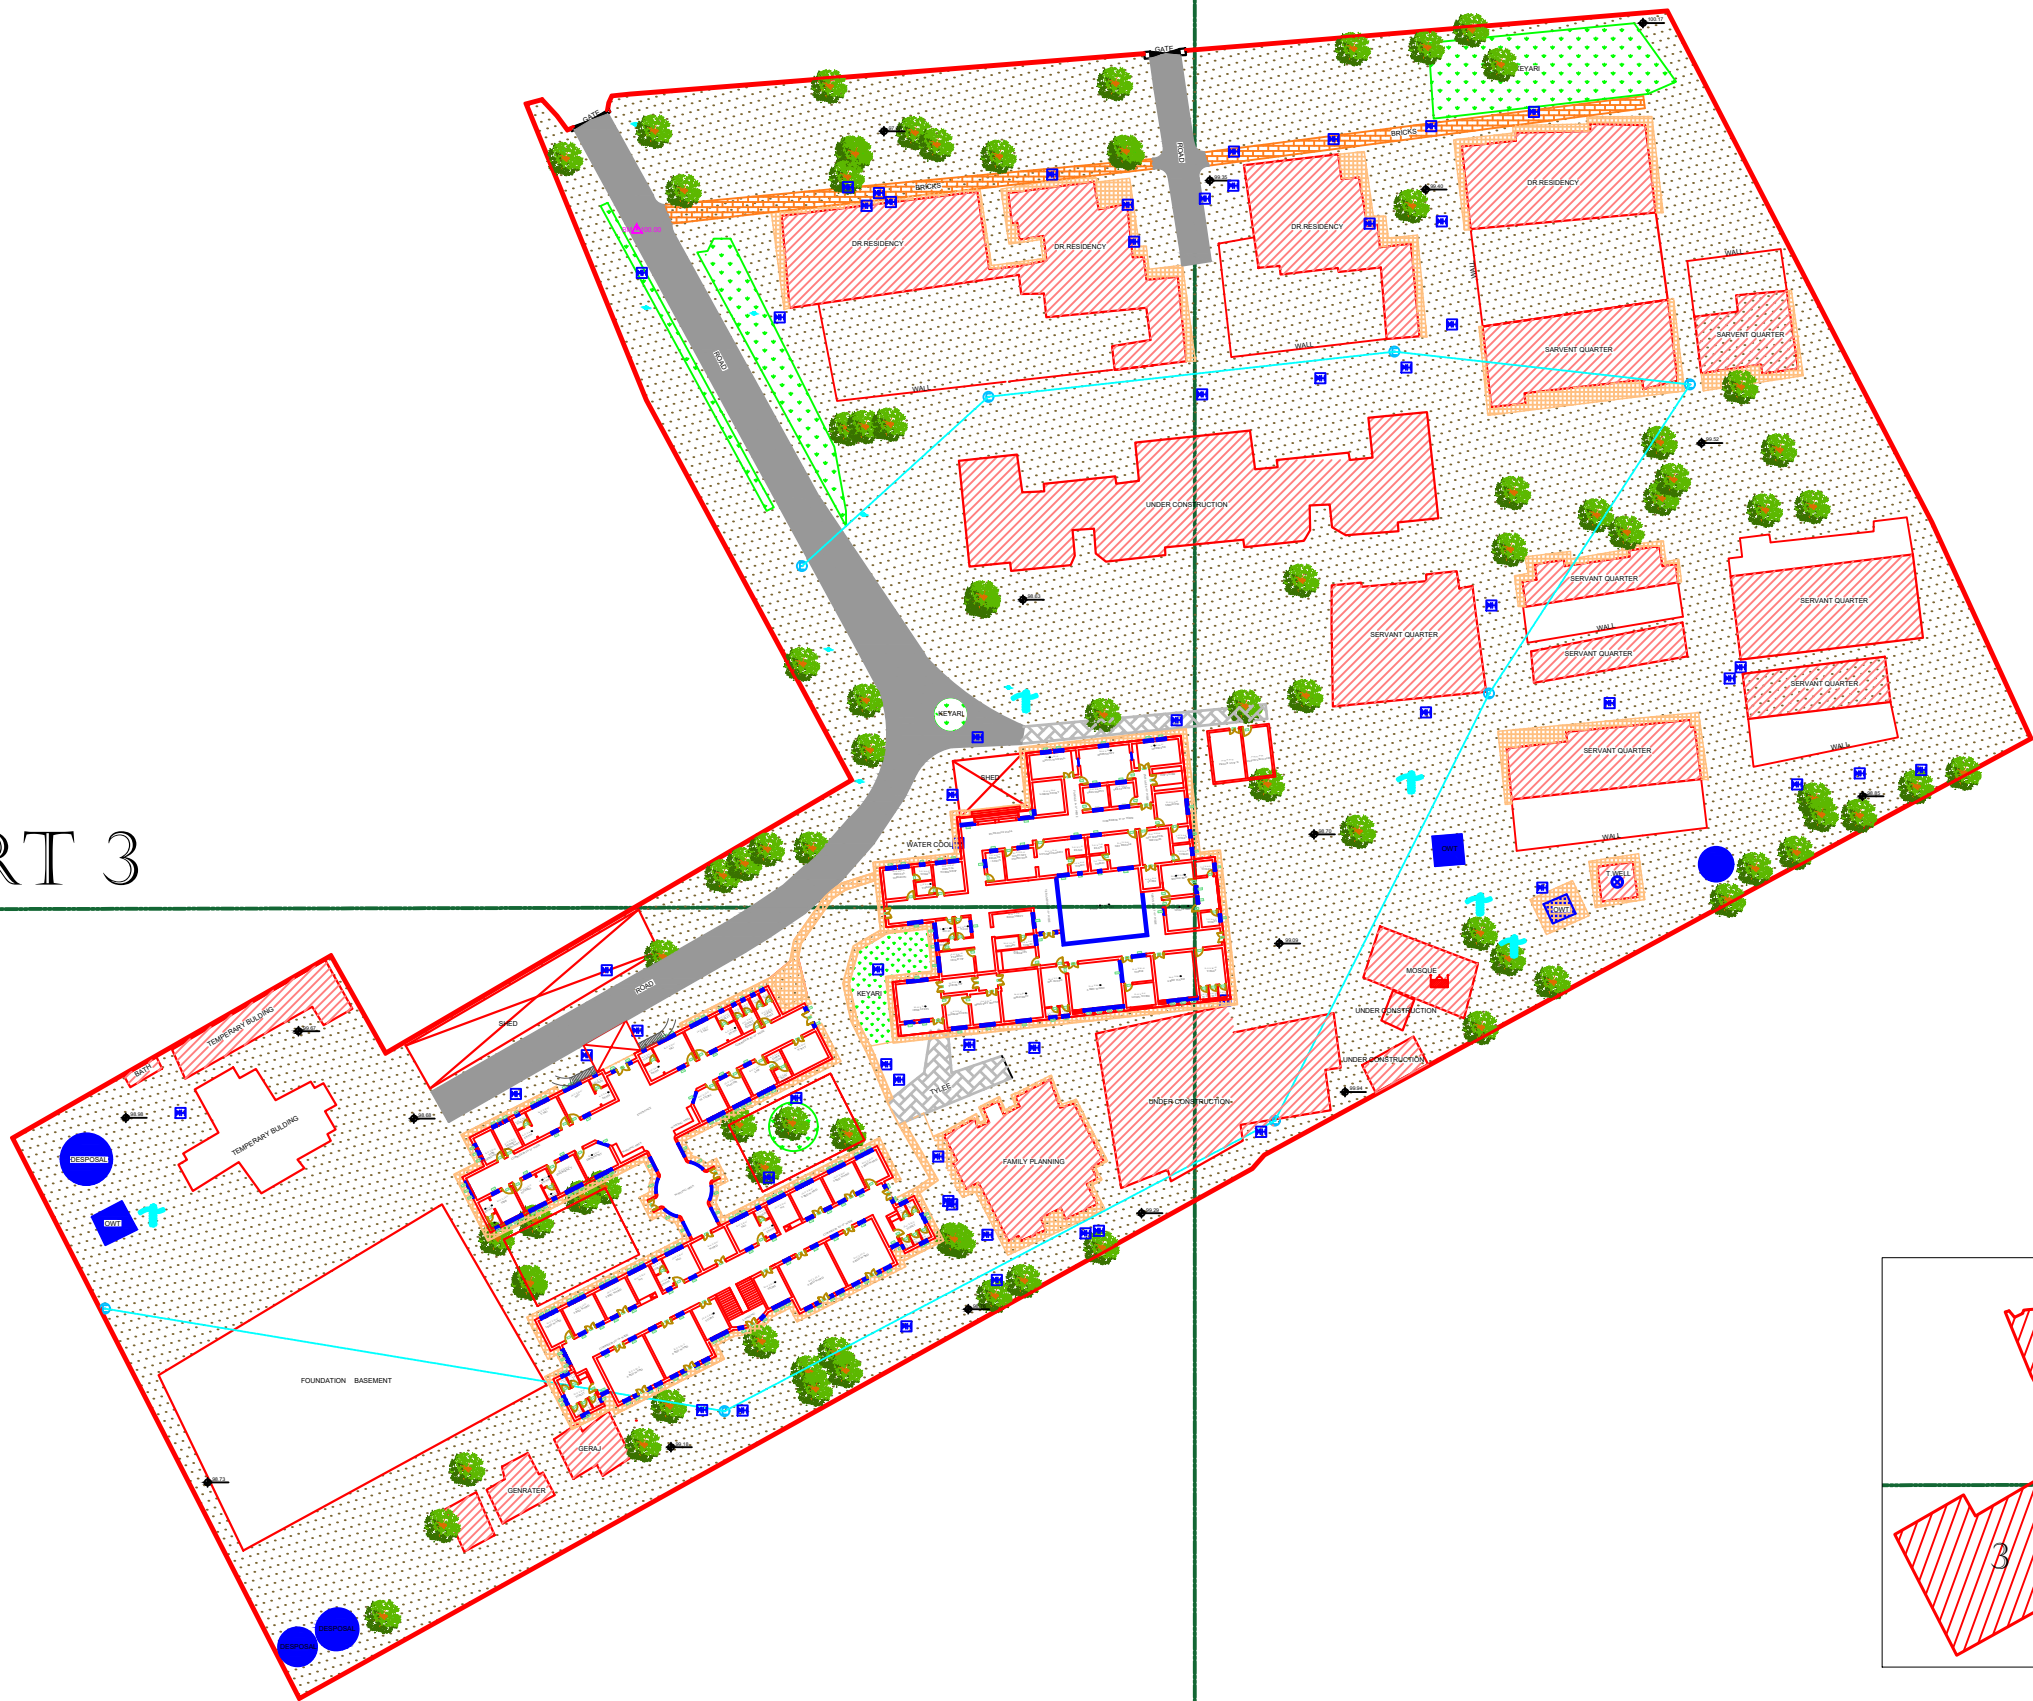


LEGENDS:

RESIDENTIAL AREA	
ROAD	
WALL	
POWER LINE	
OHT	
TREE	
MAN HOLE	
TUBE WELL	
LIGHT POLE	
LAWNS	
EARTHEN AREAS	
ASPHALTS ROADS	
TOUGH PAVERS	
P.C.C / PLINTH PROTECTION	
BOUNDARY WALL	
BRICK PAVERS / SOLING	
DRAIN	
TAP	
HAND PUMP	
AIR CONDITIONER	
TUBE LIGHT	
FAN	
ROOF LIGHT	
BULB	

AREA	
AREA WITHIN BOUNDARY WALL	276243.93 SFT
AREA OF CLINICAL BLOCK	25528.57 SFT
PLINTH AREA OF BLOCK	25528.57 SFT

OPENING SCHEDULE OF DOORS AND WINDOWS					
DOORS	WIDTH	HEIGHT	WINDOWS	WIDTH	HEIGHT
D1	5'-0"	7'-0"	W1	3'-0"	5'-0"
D2	4'-0"	7'-0"	W2	3'-6"	5'-0"
D3	3'-6"	7'-0"	W3	6'-0"	5'-0"
D4	3'-0"	7'-0"	W4	4'-6"	5'-0"
D5	2'-6"	7'-0"	W5	8'-6"	5'-0"
D6	6'-0"	7'-0"	W6	7'-0"	5'-0"
VENTS	WIDTH	HEIGHT	W7	2'-6"	5'-0"
V1	1'-6"	2'-0"	W8	4'-0"	5'-0"
V2	2'-0"	2'-0"	W9	5'-0"	5'-0"
V3	3'-0"	2'-0"	W0	2'-0"	5'-0"

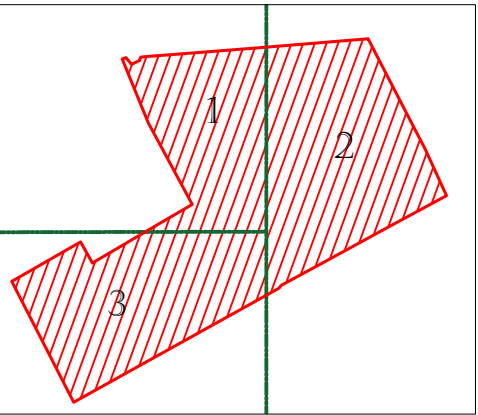

Project:
**CAD MAPPING OF TEHSIL
HEAD QUARTER HOSPITALS,
PUNJAB**

Client:

GOVERNMENT OF THE PUNJAB
PRIMARY & SECONDARY
HEALTHCARE DEPARTMENT

Consultant:



SKAFS CONSULTANT (Pvt.)
Limited
ENGINEERING AND ENVIRONMENT
CONSULTANT

Drawing Title:
**THQ JHUMRA
HOSPITAL MASTER PLAN**

Drawing No.
SKAFS/JHUMRA/03

MASTER PLAN OF THQ HOSPITAL JHUMRA

PART 1

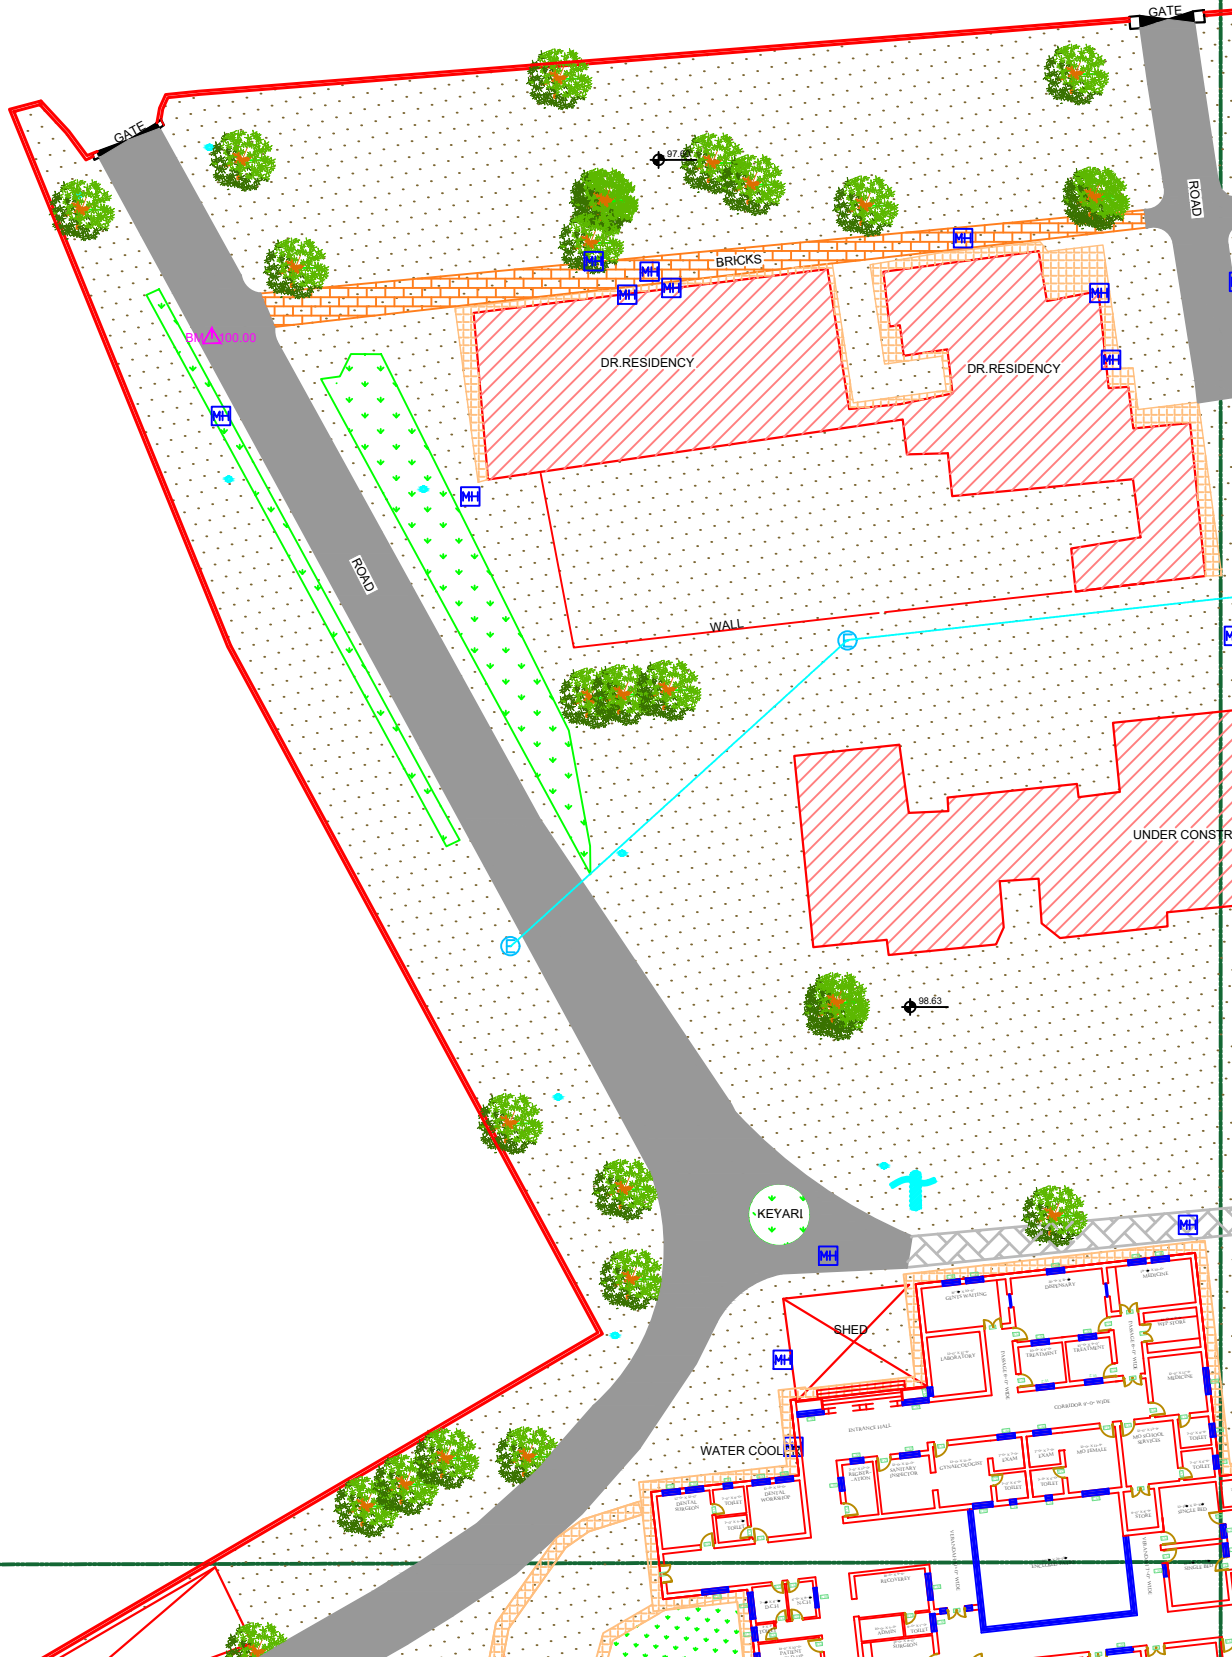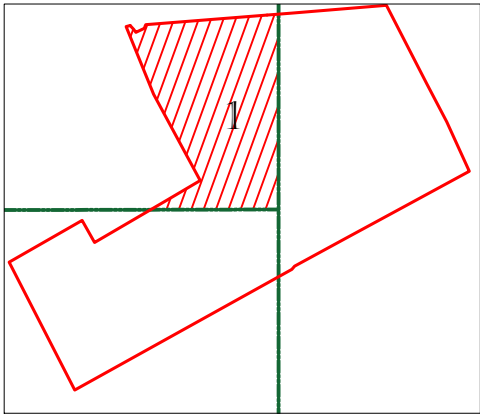

LEGENDS:

RESIDENTIAL AREA	
ROAD	
WALL	
POWER LINE	
OHT	
TREE	
MAN HOLE	
TUBE WELL	
LIGHT POLE	
LAWNS	
EARTHEN AREAS	
ASPHALTS ROADS	
TOUGH PAVERS	
P.C.C / PLINTH PROTECTION	
BOUNDARY WALL	
BRICK PAVERS / SOLING	
DRAIN	
TAP	
HAND PUMP	
AIR CONDITIONER	
TUBE LIGHT	
FAN	
ROOF LIGHT	
BULB	

AREA	
AREA WITHIN BOUNDARY WALL	276243.93 SFT
AREA OF CLINICAL BLOCK	25528.57 SFT
PLINTH AREA OF BLOCK	25528.57 SFT

OPENING SCHEDULE OF DOORS AND WINDOWS					
DOORS	WIDTH	HIGHT	WINDOWS	WIDTH	HIGHT
D1	5'-0"	7'-0"	W1	3'-0"	5'-0"
D2	4'-0"	7'-0"	W2	3'-6"	5'-0"
D3	3'-6"	7'-0"	W3	6'-0"	5'-0"
D4	3'-0"	7'-0"	W4	4'-6"	5'-0"
D5	2'-6"	7'-0"	W5	8'-6"	5'-0"
D6	6'-0"	7'-0"	W6	7'-0"	5'-0"
VENTS	WIDTH	HIGHT	W7	2'-6"	5'-0"
V1	1'-6"	2'-0"	W8	4'-0"	5'-0"
V2	2'-0"	2'-0"	W9	5'-0"	5'-0"
V3	3'-0"	2'-0"	W0	2'-0"	5'-0"

Project:
**CAD MAPPING OF TEHSIL
HEAD QUARTER HOSPITALS,
PUNJAB**



Client: GOVERNMENT OF THE PUNJAB PRIMARY & SECONDARY HEALTHCARE DEPARTMENT	Consultant: SKAFS CONSULTANT (Pvt.) Limited ENGINEERING AND ENVIRONMENT CONSULTANT
---	--

Drawing Title:
**THQ JHUMRA
HOSPITAL MASTER PLAN PART 1**

Drawing No.
SKAFS/JHUMRA/04

MASTER PLAN OF THQ HOSPITAL JHUMRA

PART 2

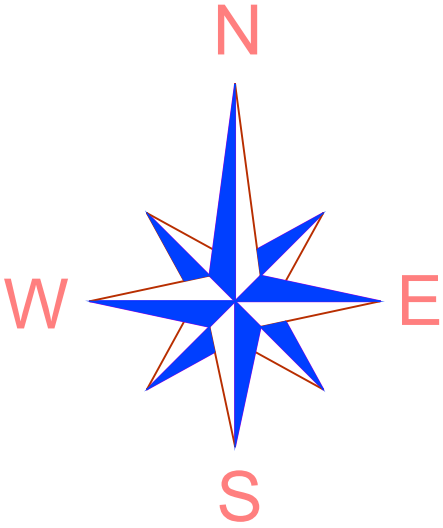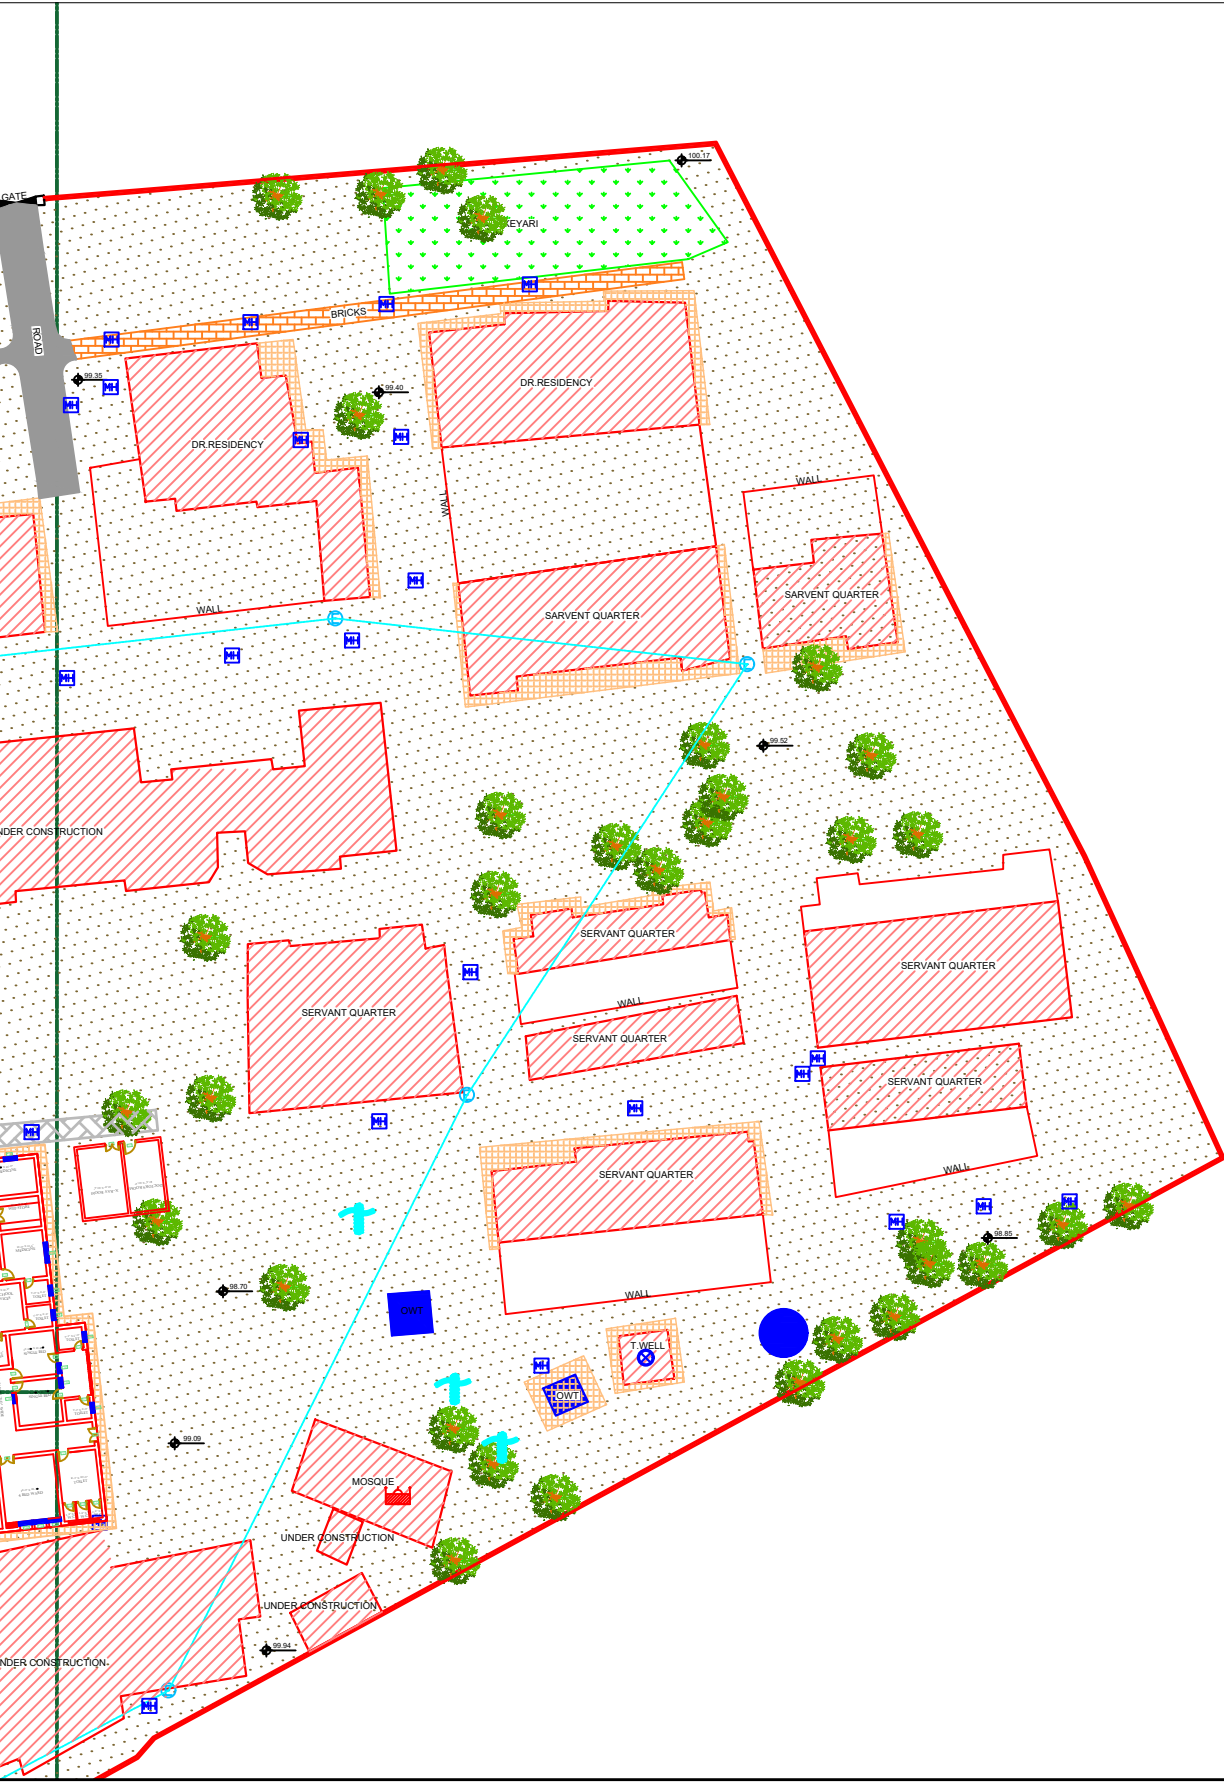

LEGENDS:

RESIDENTIAL AREA	
ROAD	
WALL	
POWER LINE	
OHT	
TREE	
MAN HOLE	
TUBE WELL	
LIGHT POLE	
LAWNS	
EARTHEN AREAS	
ASPHALTS ROADS	
TOUGH PAVERS	
P.C.C / PLINTH PROTECTION	
BOUNDARY WALL	
BRICK PAVERS / SOLING	
DRAIN	
TAP	
HAND PUMP	
AIR CONDITIONER	
TUBE LIGHT	
FAN	
ROOF LIGHT	
BULB	

AREA	
AREA WITHIN BOUNDARY WALL	276243.93 SFT
AREA OF CLINICAL BLOCK	25528.57 SFT
PLINTH AREA OF BLOCK	25528.57 SFT


OPENING SCHEDULE OF DOORS AND WINDOWS					
DOORS	WIDTH	HEIGHT	WINDOWS	WIDTH	HEIGHT
D1	5'-0"	7'-0"	W1	3'-0"	5'-0"
D2	4'-0"	7'-0"	W2	3'-6"	5'-0"
D3	3'-6"	7'-0"	W3	6'-0"	5'-0"
D4	3'-0"	7'-0"	W4	4'-6"	5'-0"
D5	2'-6"	7'-0"	W5	8'-6"	5'-0"
D6	6'-0"	7'-0"	W6	7'-0"	5'-0"
VENTS	WIDTH	HEIGHT	W7	2'-6"	5'-0"
V1	1'-6"	2'-0"	W8	4'-0"	5'-0"
V2	2'-0"	2'-0"	W9	5'-0"	5'-0"
V3	3'-0"	2'-0"	W0	2'-0"	5'-0"

Project:
**CAD MAPPING OF TEHSIL
HEAD QUARTER HOSPITALS,
PUNJAB**

Client: GOVERNMENT OF THE PUNJAB PRIMARY & SECONDARY HEALTHCARE DEPARTMENT	Consultant: SKAFS CONSULTANT (Pvt.) Limited ENGINEERING AND ENVIRONMENT CONSULTANT
---	--

Drawing Title: **THQ JHUMRA
HOSPITAL MASTER PLAN PART 2**

Drawing No. **SKAFS/JHUMRA/05**

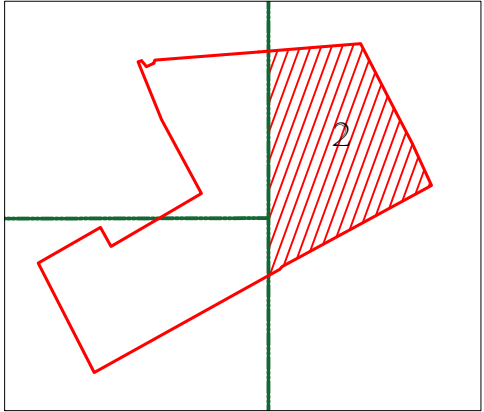

MASTER PLAN OF THQ HOSPITAL JHUMRA

PART 3



LEGENDS:

RESIDENTIAL AREA	
ROAD	
WALL	
POWER LINE	
OHT	
TREE	
MAN HOLE	
TUBE WELL	
LIGHT POLE	
LAWNS	
EARTHEN AREAS	
ASPHALTS ROADS	
TOUGH PAVERS	
P.C.C / PLINTH PROTECTION	
BOUNDARY WALL	
BRICK PAVERS / SOLING	
DRAIN	
TAP	
HAND PUMP	
AIR CONDITIONER	
TUBE LIGHT	
FAN	
ROOF LIGHT	
BULB	

AREA

AREA WITHIN BOUNDARY WALL	276243.93 SFT
AREA OF CLINICAL BLOCK	25528.57 SFT
PLINTH AREA OF BLOCK	25528.57 SFT

OPENING SCHEDULE OF DOORS AND WINDOWS

DOORS	WIDTH	HEIGHT	WINDOWS	WIDTH	HEIGHT
D1	5'-0"	7'-0"	W1	3'-0"	5'-0"
D2	4'-0"	7'-0"	W2	3'-6"	5'-0"
D3	3'-6"	7'-0"	W3	6'-0"	5'-0"
D4	3'-0"	7'-0"	W4	4'-6"	5'-0"
D5	2'-6"	7'-0"	W5	8'-6"	5'-0"
D6	6'-0"	7'-0"	W6	7'-0"	5'-0"
VENTS	WIDTH	HEIGHT	W7	2'-6"	5'-0"
V1	1'-6"	2'-0"	W8	4'-0"	5'-0"
V2	2'-0"	2'-0"	W9	5'-0"	5'-0"
V3	3'-0"	2'-0"	W0	2'-0"	5'-0"

Project: CAD MAPPING OF TEHSIL HEAD QUARTER HOSPITALS, PUNJAB

Client: GOVERNMENT OF THE PUNJAB
PRIMARY & SECONDARY
HEALTHCARE DEPARTMENT

Consultant: SKAFS CONSULTANT (Pvt.)
Limited
ENGINEERING AND ENVIRONMENT
CONSULTANT

Drawing Title: THQ JHUMRA
HOSPITAL MASTER PLAN PART 3

Drawing No. SKAFS/JHUMRA/06

Drawing No. **SKAFS/JHUMBA/07**

CLINICAL BLOCK OF THQ HOSPITAL JHUMRA

GROUND FLOOR PART 1

LEGENDS:

RESIDENTIAL AREA

ROAD

WALL

POWER LINE

OHT

TREE

MAN HOLE

TUBE WELL

LIGHT POLE

LAWNS

EARTHEN AREAS

ASPHALTS ROADS

TOUGH PAVERS

P.C.C / PLINTH PROTECTION

BOUNDARY WALL

BRICK PAVERS / SOLING

DRAIN

TAP

HAND PUMP

AIR CONDITIONER

TUBE LIGHT

FAN

ROOF LIGHT

BULB

AREA

AREA WITHIN BOUNDARY WALL

276243.93 SFT

AREA OF CLINICAL BLOCK

25528.57 SFT

PLINTH AREA OF BLOCK

25528.57 SFT

OPENING SCHEDULE OF DOORS AND WINDOWS

DOORS	WIDTH	HIGHT	WINDOWS	WIDTH	HIGHT
D1	5'-0"	7'-0"	W1	3'-0"	5'-0"
D2	4'-0"	7'-0"	W2	3'-6"	5'-0"
D3	3'-6"	7'-0"	W3	6'-0"	5'-0"
D4	3'-0"	7'-0"	W4	4'-6"	5'-0"
D5	2'-6"	7'-0"	W5	8'-6"	5'-0"
D6	6'-0"	7'-0"	W6	7'-0"	5'-0"
VENTS	WIDTH	HEIGHT	W7	2'-6"	5'-0"
V1	1'-6"	2'-0"	W8	4'-0"	5'-0"
V2	2'-0"	2'-0"	W9	5'-0"	5'-0"
V3	3'-0"	2'-0"	W0	2'-0"	5'-0"

Project:

CAD MAPPING OF TEHSIL HEAD QUARTER HOSPITALS, PUNJAB

Client:

GOVERNMENT OF THE PUNJAB
PRIMARY & SECONDARY
HEALTHCARE DEPARTMENT

Consultant:


SKAFS CONSULTANT (Pvt.) Limited
ENGINEERING AND ENVIRONMENT
CONSULTANT

Drawing Title:

THQ JHUMRA
CLINICAL BLOCK PLAN (PART 1)


Drawing No.

SKAFS/JHUMRA/08

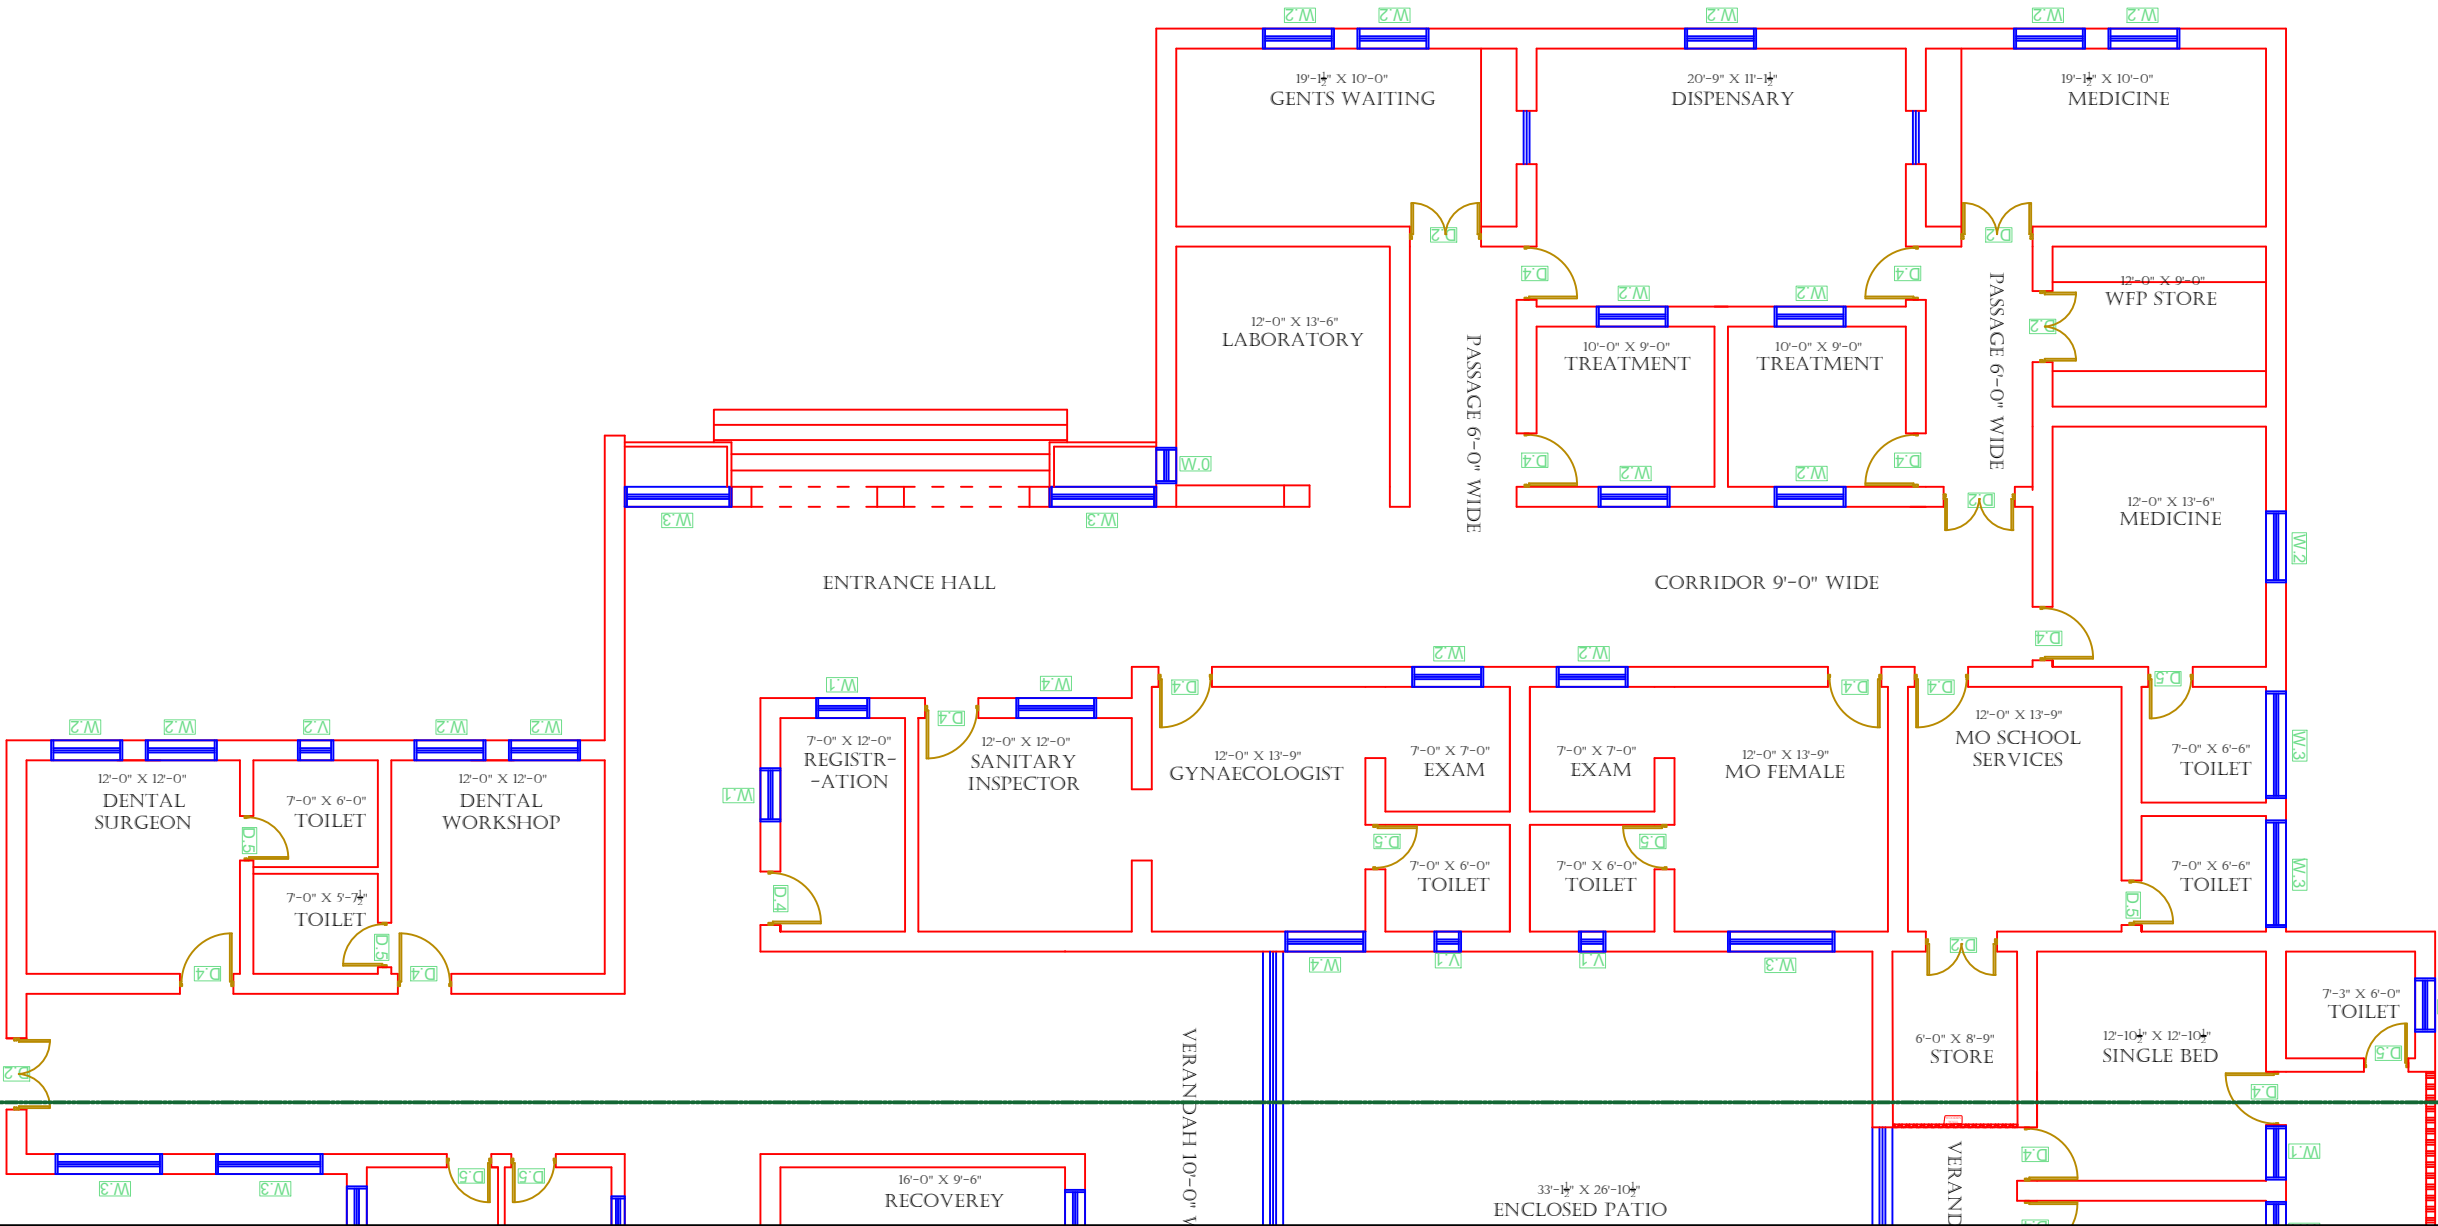

CLINICAL BLOCK OF THQ HOSPITAL JHUMRA

GROUND FLOOR PART 2

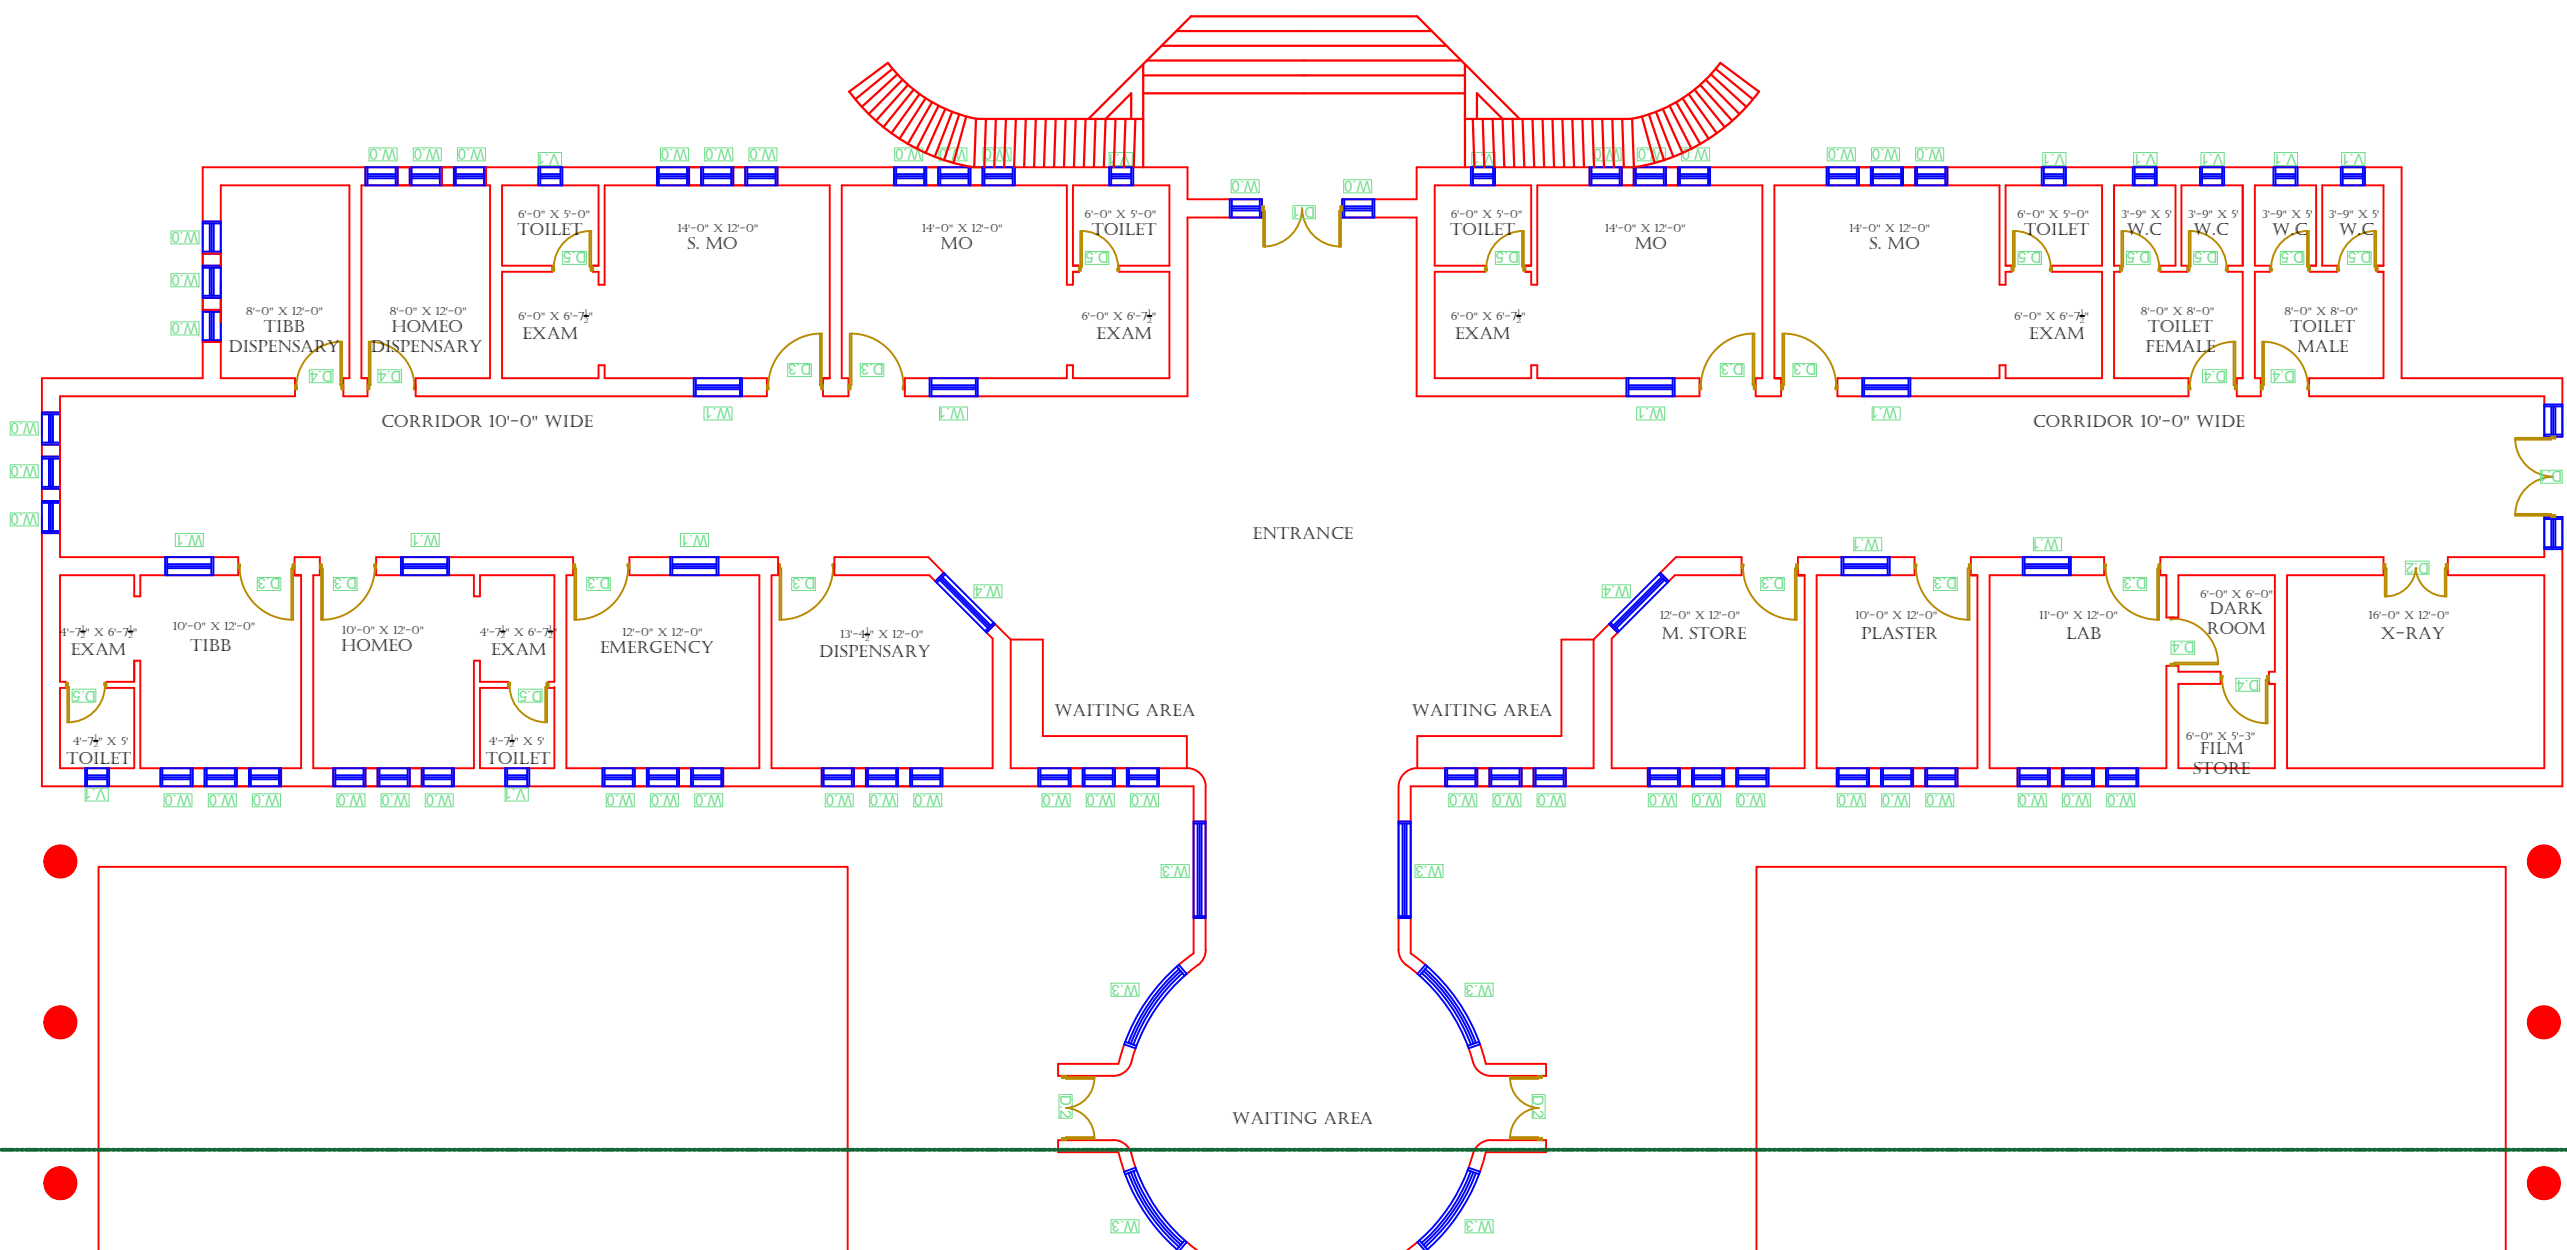

LEGENDS:

RESIDENTIAL AREA	
ROAD	
WALL	
POWER LINE	
OHT	
TREE	
MAN HOLE	
TUBE WELL	
LIGHT POLE	
LAWNS	
EARTHEN AREAS	
ASPHALTS ROADS	
TOUGH PAVERS	
P.C.C / PLINTH PROTECTION	
BOUNDARY WALL	
BRICK PAVERS / SOLING	
DRAIN	
TAP	
HAND PUMP	HP
AIR CONDITIONER	
TUBE LIGHT	
FAN	
ROOF LIGHT	
BULB	

AREA	
AREA WITHIN BOUNDARY WALL	276243.93 SFT
AREA OF CLINICAL BLOCK	25528.57 SFT
PLINTH AREA OF BLOCK	25528.57 SFT

OPENING SCHEDULE OF DOORS AND WINDOWS							
DOORS	WIDTH	HIGHT	WINDOWS	WIDTH	HIGHT		
D1	5'-0"	7'-0"	W1	3'-0"	5'-0"		
D2	4'-0"	7'-0"	W2	3'-6"	5'-0"		
D3	3'-6"	7'-0"	W3	6'-0"	5'-0"		
D4	3'-0"	7'-0"	W4	4'-6"	5'-0"		
D5	2'-6"	7'-0"	W5	8'-6"	5'-0"		
D6	6'-0"	7'-0"	W6	7'-0"	5'-0"		
VENTS	WIDTH	HIGHT	W7	2'-6"	5'-0"		
V1	1'-6"	2'-0"	W8	4'-0"	5'-0"		
V2	2'-0"	2'-0"	W9	5'-0"	5'-0"		
V3	3'-0"	2'-0"	W0	2'-0"	5'-0"		

Project:

CAD MAPPING OF TEHSIL HEAD QUARTER HOSPITALS, PUNJAB

Client:	Consultant:
 GOVERNMENT OF THE PUNJAB PRIMARY & SECONDARY HEALTHCARE DEPARTMENT	 SKAFS CONSULTANT (Pvt.) Limited ENGINEERING AND ENVIRONMENT CONSULTANT


Drawing Title:

**THQ JHUMRA
CLINICAL BLOCK PLAN (PART 2)**

Drawing No.

SKAFS/JHUMRA/09

CLINICAL BLOCK OF THQ HOSPITAL JHUMRA
GROUND FLOOR PART 3

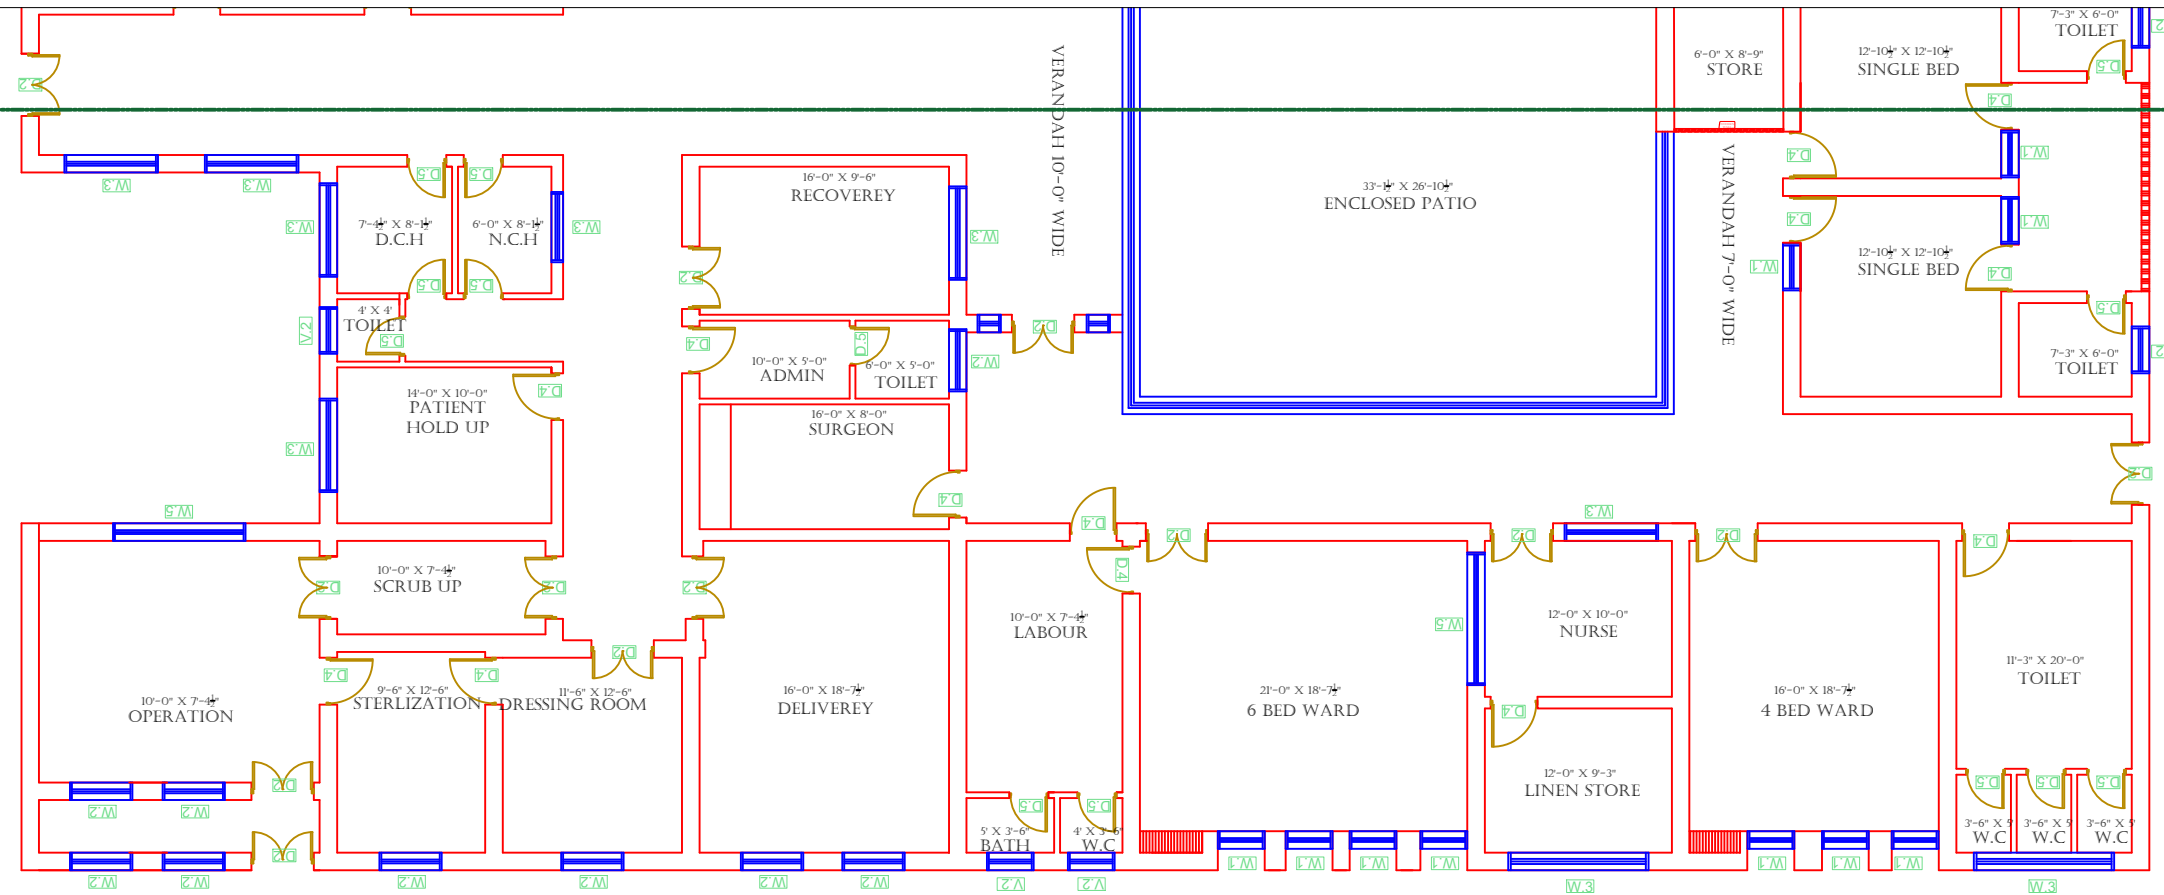

LEGENDS:

RESIDENTIAL AREA	
ROAD	
WALL	
POWER LINE	
OHT	
TREE	
MAN HOLE	
TUBE WELL	
LIGHT POLE	
LAWNS	
EARTHEN AREAS	
ASPHALT'S ROADS	
TOUGH PAVERS	
P.C.C / PLINTH PROTECTION	
BOUNDARY WALL	
BRICK PAVERS / SOLING	
DRAIN	
TAP	
HAND PUMP	
AIR CONDITIONER	
TUBE LIGHT	
FAN	
ROOF LIGHT	
BULB	

AREA

AREA WITHIN BOUNDARY WALL	276243.93 SFT
AREA OF CLINICAL BLOCK	25528.57 SFT
PLINTH AREA OF BLOCK	25528.57 SFT

OPENING SCHEDULE OF DOORS AND WINDOWS

DOORS	WIDTH	HEIGHT	WINDOWS	WIDTH	HEIGHT
D1	5'-0"	7'-0"	W1	3'-0"	5'-0"
D2	4'-0"	7'-0"	W2	3'-6"	5'-0"
D3	3'-6"	7'-0"	W3	6'-0"	5'-0"
D4	3'-0"	7'-0"	W4	4'-6"	5'-0"
D5	2'-6"	7'-0"	W5	8'-6"	5'-0"
D6	6'-0"	7'-0"	W6	7'-0"	5'-0"
VENTS	WIDTH	HEIGHT	W7	2'-6"	5'-0"
V1	1'-6"	2'-0"	W8	4'-0"	5'-0"
V2	2'-0"	2'-0"	W9	5'-0"	5'-0"
V3	3'-0"	2'-0"	W0	2'-0"	5'-0"

Project: **CAD MAPPING OF TEHSIL
HEAD QUARTER HOSPITALS,
PUNJAB**


Client:  GOVERNMENT OF THE PUNJAB PRIMARY & SECONDARY HEALTHCARE DEPARTMENT	Consultant:  SKAFS CONSULTANT (Pvt.) Limited <i>ENGINEERING AND ENVIRONMENT CONSULTANT</i>
--	---

Drawing Title:	THQ JHUMRA CLINICAL BLOCK PLAN (PART 3)
----------------	--

Drawing No. **SKAFS/JHUMRA/10**

CLINICAL BLOCK OF THQ HOSPITAL JHUMRA

GROUND FLOOR PART 4

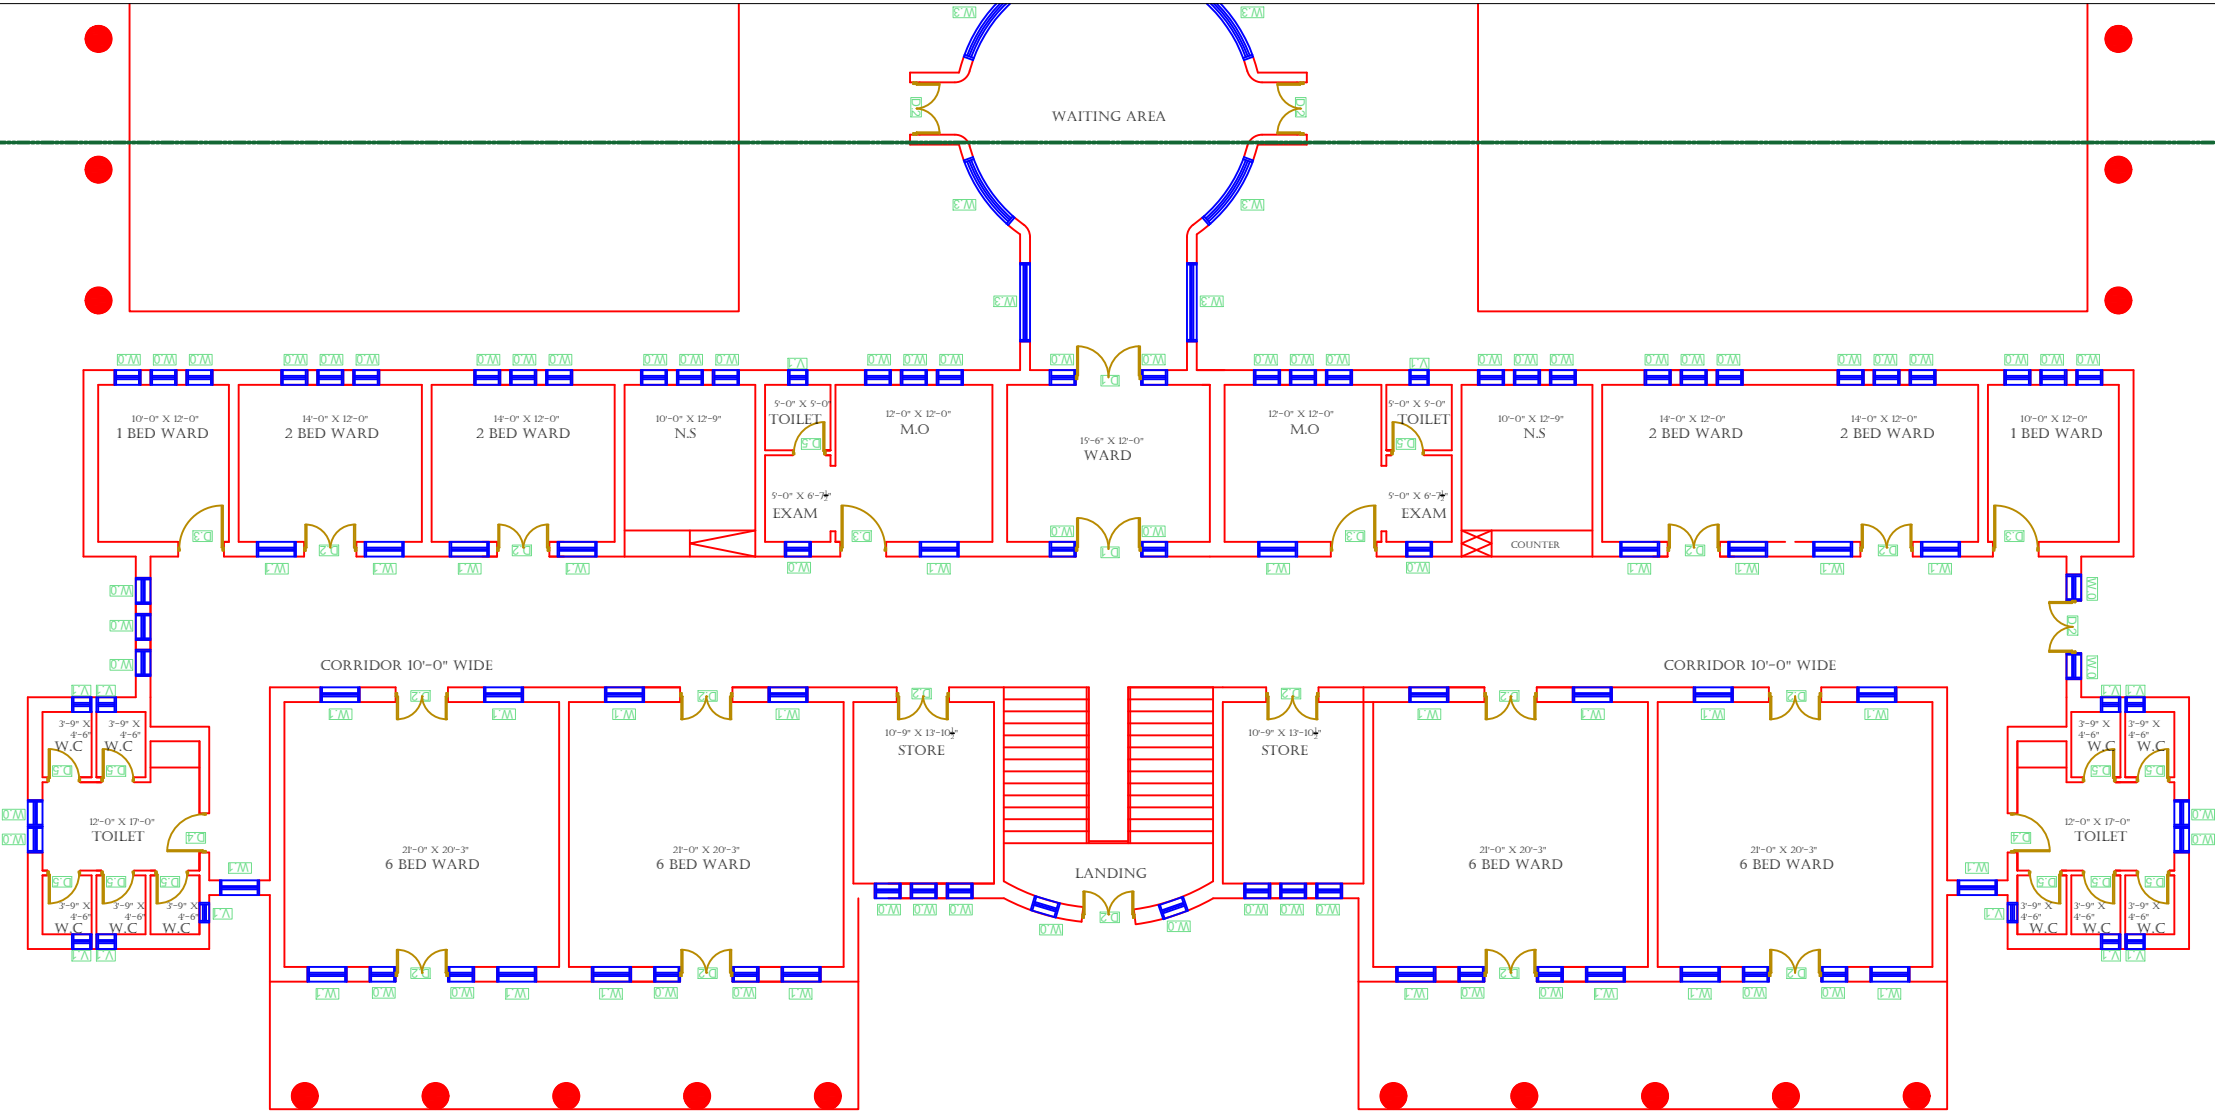

LEGENDS:

RESIDENTIAL AREA	
ROAD	
WALL	
POWER LINE	
OHT	
TREE	
MAN HOLE	
TUBE WELL	
LIGHT POLE	
LAWNS	
EARTHEN AREAS	
ASPHALTS ROADS	
TOUGH PAVERS	
P.C.C / PLINTH PROTECTION	
BOUNDARY WALL	
BRICK PAVERS / SOLING	
DRAIN	
TAP	
HAND PUMP	
AIR CONDITIONER	
TUBE LIGHT	
FAN	
ROOF LIGHT	
BULB	

AREA					
AREA WITHIN BOUNDARY WALL		276243.93 SFT			
AREA OF CLINICAL BLOCK		25528.57 SFT			
PLINTH AREA OF BLOCK		25528.57 SFT			

OPENING SCHEDULE OF DOORS AND WINDOWS					
DOORS	WIDTH	HEIGHT	WINDOWS	WIDTH	HEIGHT
D1	5'-0"	7'-0"	W1	3'-0"	5'-0"
D2	4'-0"	7'-0"	W2	3'-6"	5'-0"
D3	3'-6"	7'-0"	W3	6'-0"	5'-0"
D4	3'-0"	7'-0"	W4	4'-6"	5'-0"
D5	2'-6"	7'-0"	W5	8'-6"	5'-0"
D6	6'-0"	7'-0"	W6	7'-0"	5'-0"
VENTS	WIDTH	HEIGHT	W7	2'-6"	5'-0"
V1	1'-6"	2'-0"	W8	4'-0"	5'-0"
V2	2'-0"	2'-0"	W9	5'-0"	5'-0"
V3	3'-0"	2'-0"	W0	2'-0"	5'-0"

Project:

CAD MAPPING OF TEHSIL HEAD QUARTER HOSPITALS, PUNJAB


Client:	Consultant:
 GOVERNMENT OF THE PUNJAB PRIMARY & SECONDARY HEALTHCARE DEPARTMENT	 SKAFS CONSULTANT (Pvt.) Limited ENGINEERING AND ENVIRONMENT CONSULTANT

Drawing Title: **THQ JHUMRA CLINICAL BLOCK PLAN (PART 4)**

Drawing No. **SKAFS/JHUMRA /11**

ELECTRICAL LAYOUT PLAN OF THQ HOSPITAL JHUMRA

GROUND FLOOR

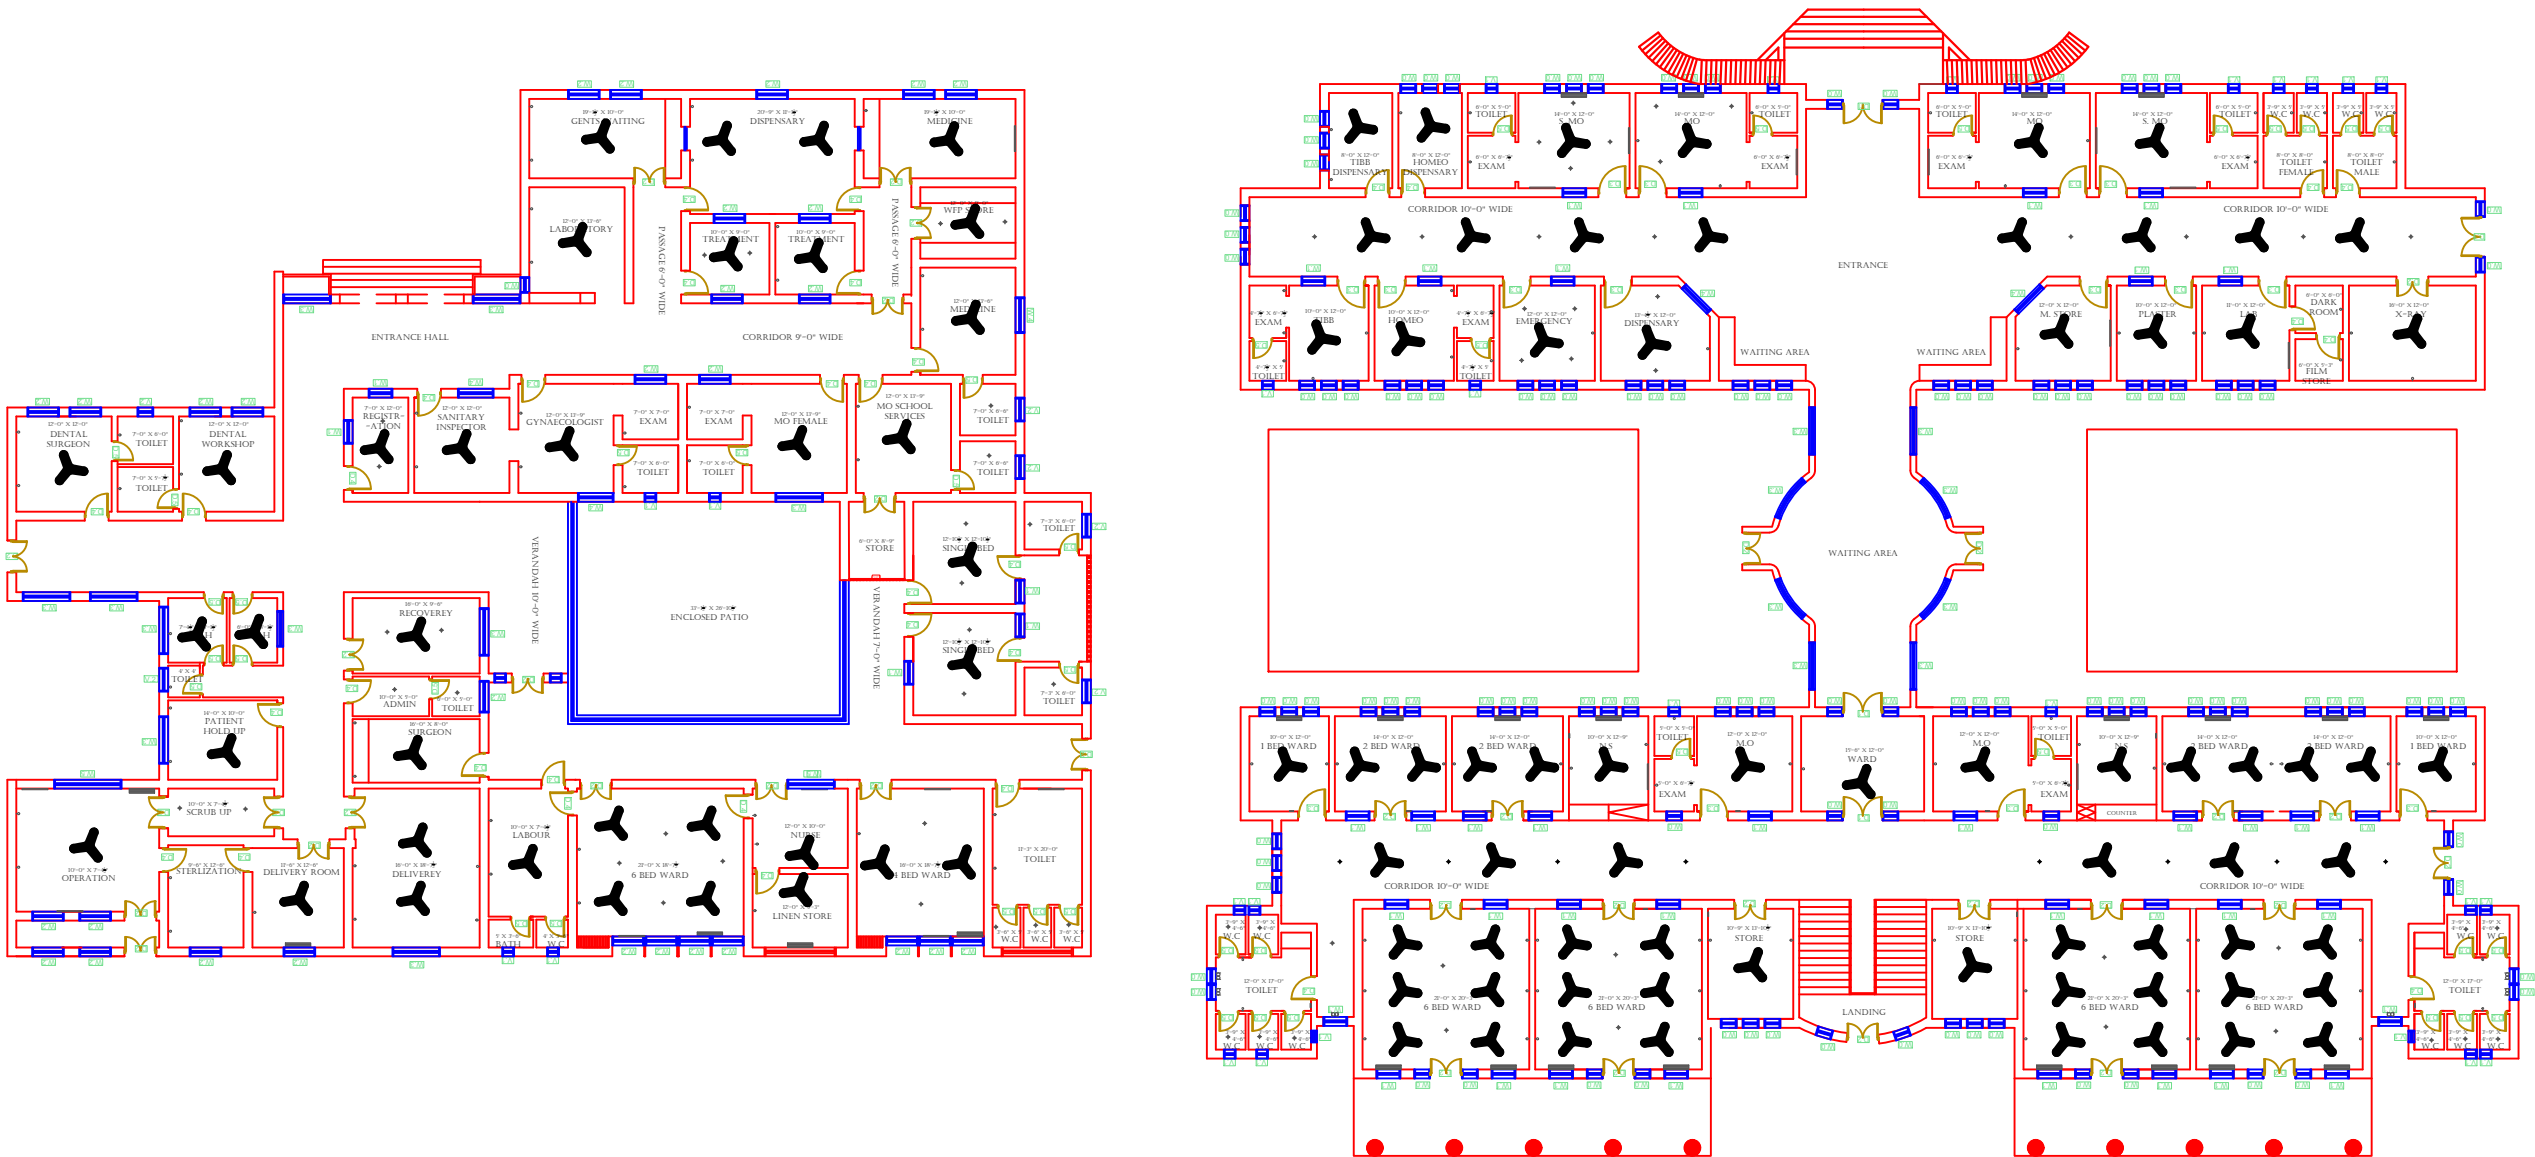

LEGENDS:

RESIDENTIAL AREA

ROAD

WALL

POWER LINE

OHT

TREE

MAN HOLE

TUBE WELL

LIGHT POLE

LAWNS

EARTHEN AREAS

ASPHALTS ROADS

TOUGH PAVERS

P.C.C / PLINTH PROTECTION

BOUNDARY WALL

BRICK PAVERS / SOLING

DRAIN

TAP

HAND PUMP

AIR CONDITIONER

TUBE LIGHT

FAN

ROOF LIGHT

BULB

AREA					
AREA WITHIN BOUNDARY WALL		276243.93 SFT			
AREA OF CLINICAL BLOCK		25528.57 SFT			
PLINTH AREA OF BLOCK		25528.57 SFT			

OPENING SCHEDULE OF DOORS AND WINDOWS					
DOORS	WIDTH	HIGHT	WINDOWS	WIDTH	HIGHT
D1	5'-0"	7'-0"	W1	3'-0"	5'-0"
D2	4'-0"	7'-0"	W2	3'-6"	5'-0"
D3	3'-6"	7'-0"	W3	6'-0"	5'-0"
D4	3'-0"	7'-0"	W4	4'-6"	5'-0"
D5	2'-6"	7'-0"	W5	8'-6"	5'-0"
D6	6'-0"	7'-0"	W6	7'-0"	5'-0"
VENTS	WIDTH	HIGHT	W7	2'-6"	5'-0"
V1	1'-6"	2'-0"	W8	4'-0"	5'-0"
V2	2'-0"	2'-0"	W9	5'-0"	5'-0"
V3	3'-0"	2'-0"	W0	2'-0"	5'-0"

Project:

CAD MAPPING OF TEHSIL
HEAD QUARTER HOSPITALS,
PUNJAB

Client:

GOVERNMENT OF THE PUNJAB
PRIMARY & SECONDARY
HEALTHCARE DEPARTMENT

Consultant:

SKAFS CONSULTANT (Pvt.)
Limited
ENGINEERING AND ENVIRONMENT
CONSULTANT

Drawing Title:

THQ JHUMRA
ELECTRICAL PLAN (GROUND FLOOR)

Drawing No.

SKAFS/JHUMRA /12