


MASTER PLAN OF THQ HOSPITAL LALLIAN

PART 1

PART 2

PART 3

PART 4

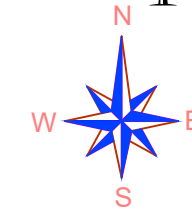


Legends:

Residential Area	
Road	
Wall	
Power Line	
OHT	
Tree	
Man Hole	
Tube Well	
Light Pole	
Lawns	
Earthen Areas	
Asphalts Roads	
Tough Pavers	
P.C.C / Plinth Protection	
Boundary Wall	
Brick Pavers / Soling	
Drain	
Tap	
Hand Pump	
Air Conditioner	
Tube Light	
Fan	
Roof Light	
Bulb	

AREA	
AREA WITHIN BOUNDARY WALL	190422.658 Sft
AREA OF CLINICAL BLOCK	30693.85 Sft
PLINTH AREA OF BLOCK	19836.813 Sft

OPENING SCHEDULE OF DOORS AND WINDOWS					
DOORS	WIDTH	HEIGHT	WINDOWS	WIDTH	HEIGHT
D2	5'-0"	7'-0"	W1	6'-0"	6'-0"
D4	3'-6"	7'-0"	W2	4'-0"	4'-0"
D5	3'-0"	7'-0"	W3	3'-6"	3'-6"
D6	2'-6"	7'-0"	W4	2'-0"	2'-0"

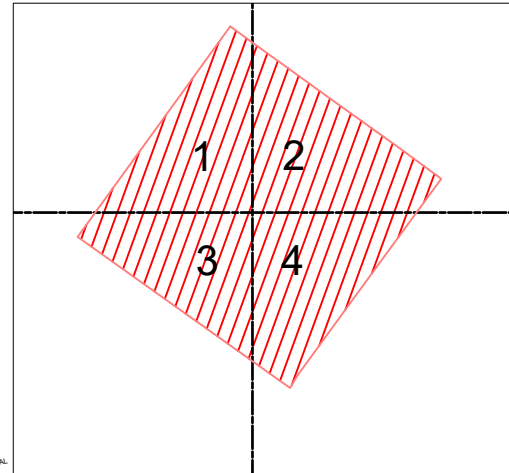

Project:
CAD MAPPING OF TEHSIL HEAD QUARTER HOSPITALS, PUNJAB


Client: GOVERNMENT OF THE PUNJAB PRIMARY & SECONDARY HEALTHCARE DEPARTMENT	Consultant: SKAFS CONSULTANT (Pvt.) Limited ENGINEERING AND ENVIRONMENT CONSULTANT
---	--

Drawing Title:
THQ LALLIAN HOSPITAL MASTER PLAN

Drawing No. **SKAFS/LALLIAN /03**

MASTER PLAN OF THQ HOSPITAL LALLIAN

PART 1

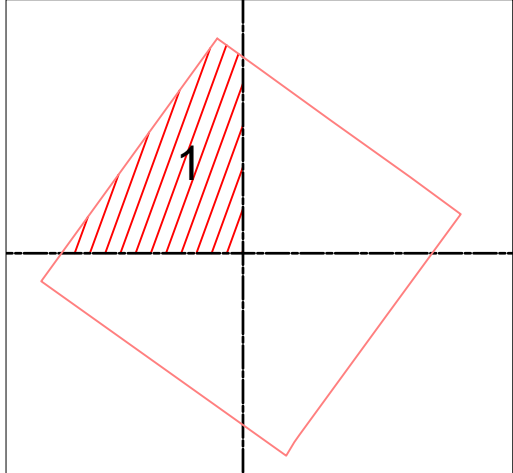

Legends:

Residential Area	
Road	
Wall	
Power Line	
OHT	
Tree	
Man Hole	
Tube Well	
Light Pole	
Lawns	
Earthen Areas	
Asphalts Roads	
Tough Pavers	
P.C.C / Plinth Protection	
Boundary Wall	
Brick Pavers / Soling	
Drain	
Tap	
Hand Pump	
Air Conditioner	
Tube Light	
Fan	
Roof Light	
Bulb	

AREA	
AREA WITHIN BOUNDARY WALL	190422.658 Sft
AREA OF CLINICAL BLOCK	30693.85 Sft
PLINTH AREA OF BLOCK	19836.813 Sft

OPENING SCHEDULE OF DOORS AND WINDOWS					
DOORS	WIDTH	HEIGHT	WINDOWS	WIDTH	HEIGHT
D2	5'-0"	7'-0"	W1	6'-0"	6'-0"
D4	3'-6"	7'-0"	W2	4'-0"	4'-0"
D5	3'-0"	7'-0"	W3	3'-6"	3'-6"
D6	2'-6"	7'-0"	W4	2'-0"	2'-0"

Project:
CAD MAPPING OF TEHSIL HEAD QUARTER HOSPITALS, PUNJAB




Client: GOVERNMENT OF THE PUNJAB PRIMARY & SECONDARY HEALTHCARE DEPARTMENT	Consultant: SKAFS CONSULTANT (Pvt.) Limited ENGINEERING AND ENVIRONMENT CONSULTANT
---	--

Drawing Title:
THQ LALLIAN HOSPITAL MASTER PLAN PART 1

Drawing No. **SKAFS/LALLIAN /04**

MASTER PLAN OF THQ HOSPITAL LALLIAN

PART 2

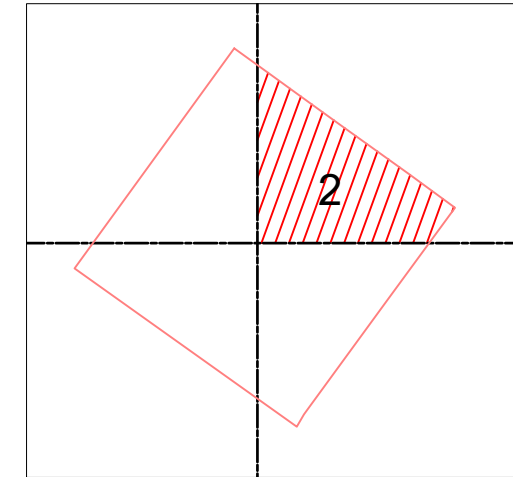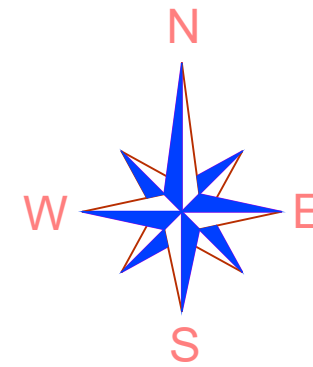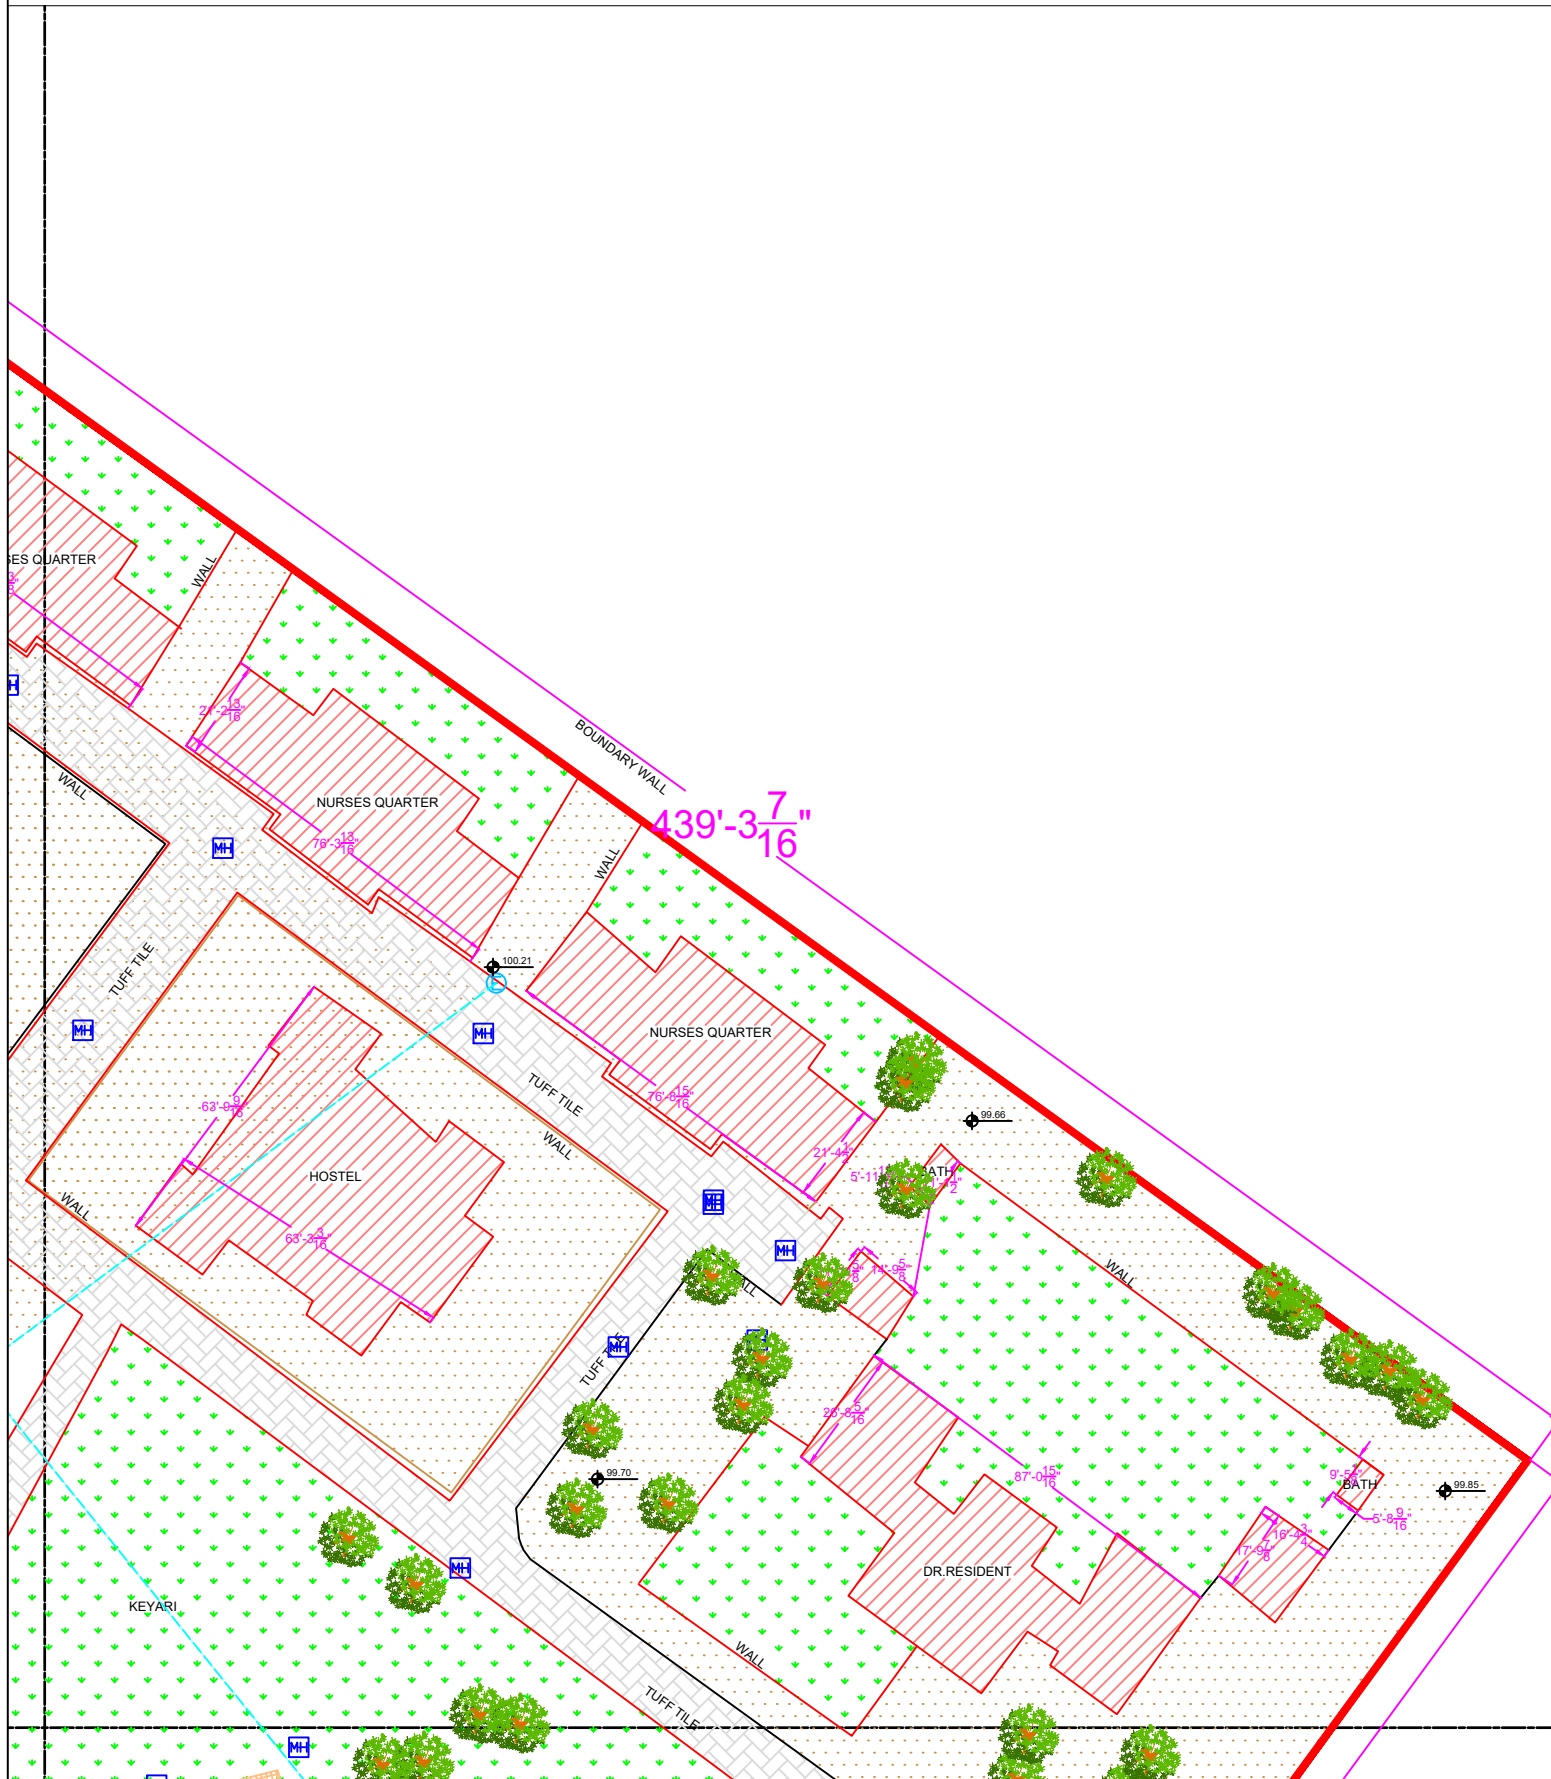

Legends:

Residential Area	
Road	
Wall	
Power Line	
OHT	
Tree	
Man Hole	
Tube Well	
Light Pole	
Lawns	
Earthen Areas	
Asphalts Roads	
Tough Pavers	
P.C.C / Plinth Protection	
Boundary Wall	
Brick Pavers / Soling	
Drain	
Tap	
Hand Pump	
Air Conditioner	
Tube Light	
Fan	
Roof Light	
Bulb	

AREA	
AREA WITHIN BOUNDARY WALL	190422.658 Sft
AREA OF CLINICAL BLOCK	30693.85 Sft
PLINTH AREA OF BLOCK	19836.813 Sft

OPENING SCHEDULE OF DOORS AND WINDOWS					
DOORS	WIDTH	HEIGHT	WINDOWS	WIDTH	HEIGHT
D2	5'-0"	7'-0"	W1	6'-0"	6'-0"
D4	3'-6"	7'-0"	W2	4'-0"	4'-0"
D5	3'-0"	7'-0"	W3	3'-6"	3'-6"
D6	2'-6"	7'-0"	W4	2'-0"	2'-0"

Project:
CAD MAPPING OF TEHSIL HEAD QUARTER HOSPITALS, PUNJAB


Client: GOVERNMENT OF THE PUNJAB PRIMARY & SECONDARY HEALTHCARE DEPARTMENT	Consultant: SKAFS CONSULTANT (Pvt.) Limited ENGINEERING AND ENVIRONMENT CONSULTANT
---	--

Drawing Title:
THQ LALLIAN HOSPITAL MASTER PLAN PART 2

Drawing No. **SKAFS/LALLIAN /05**

MASTER PLAN OF THQ HOSPITAL LALLIAN

PART 3

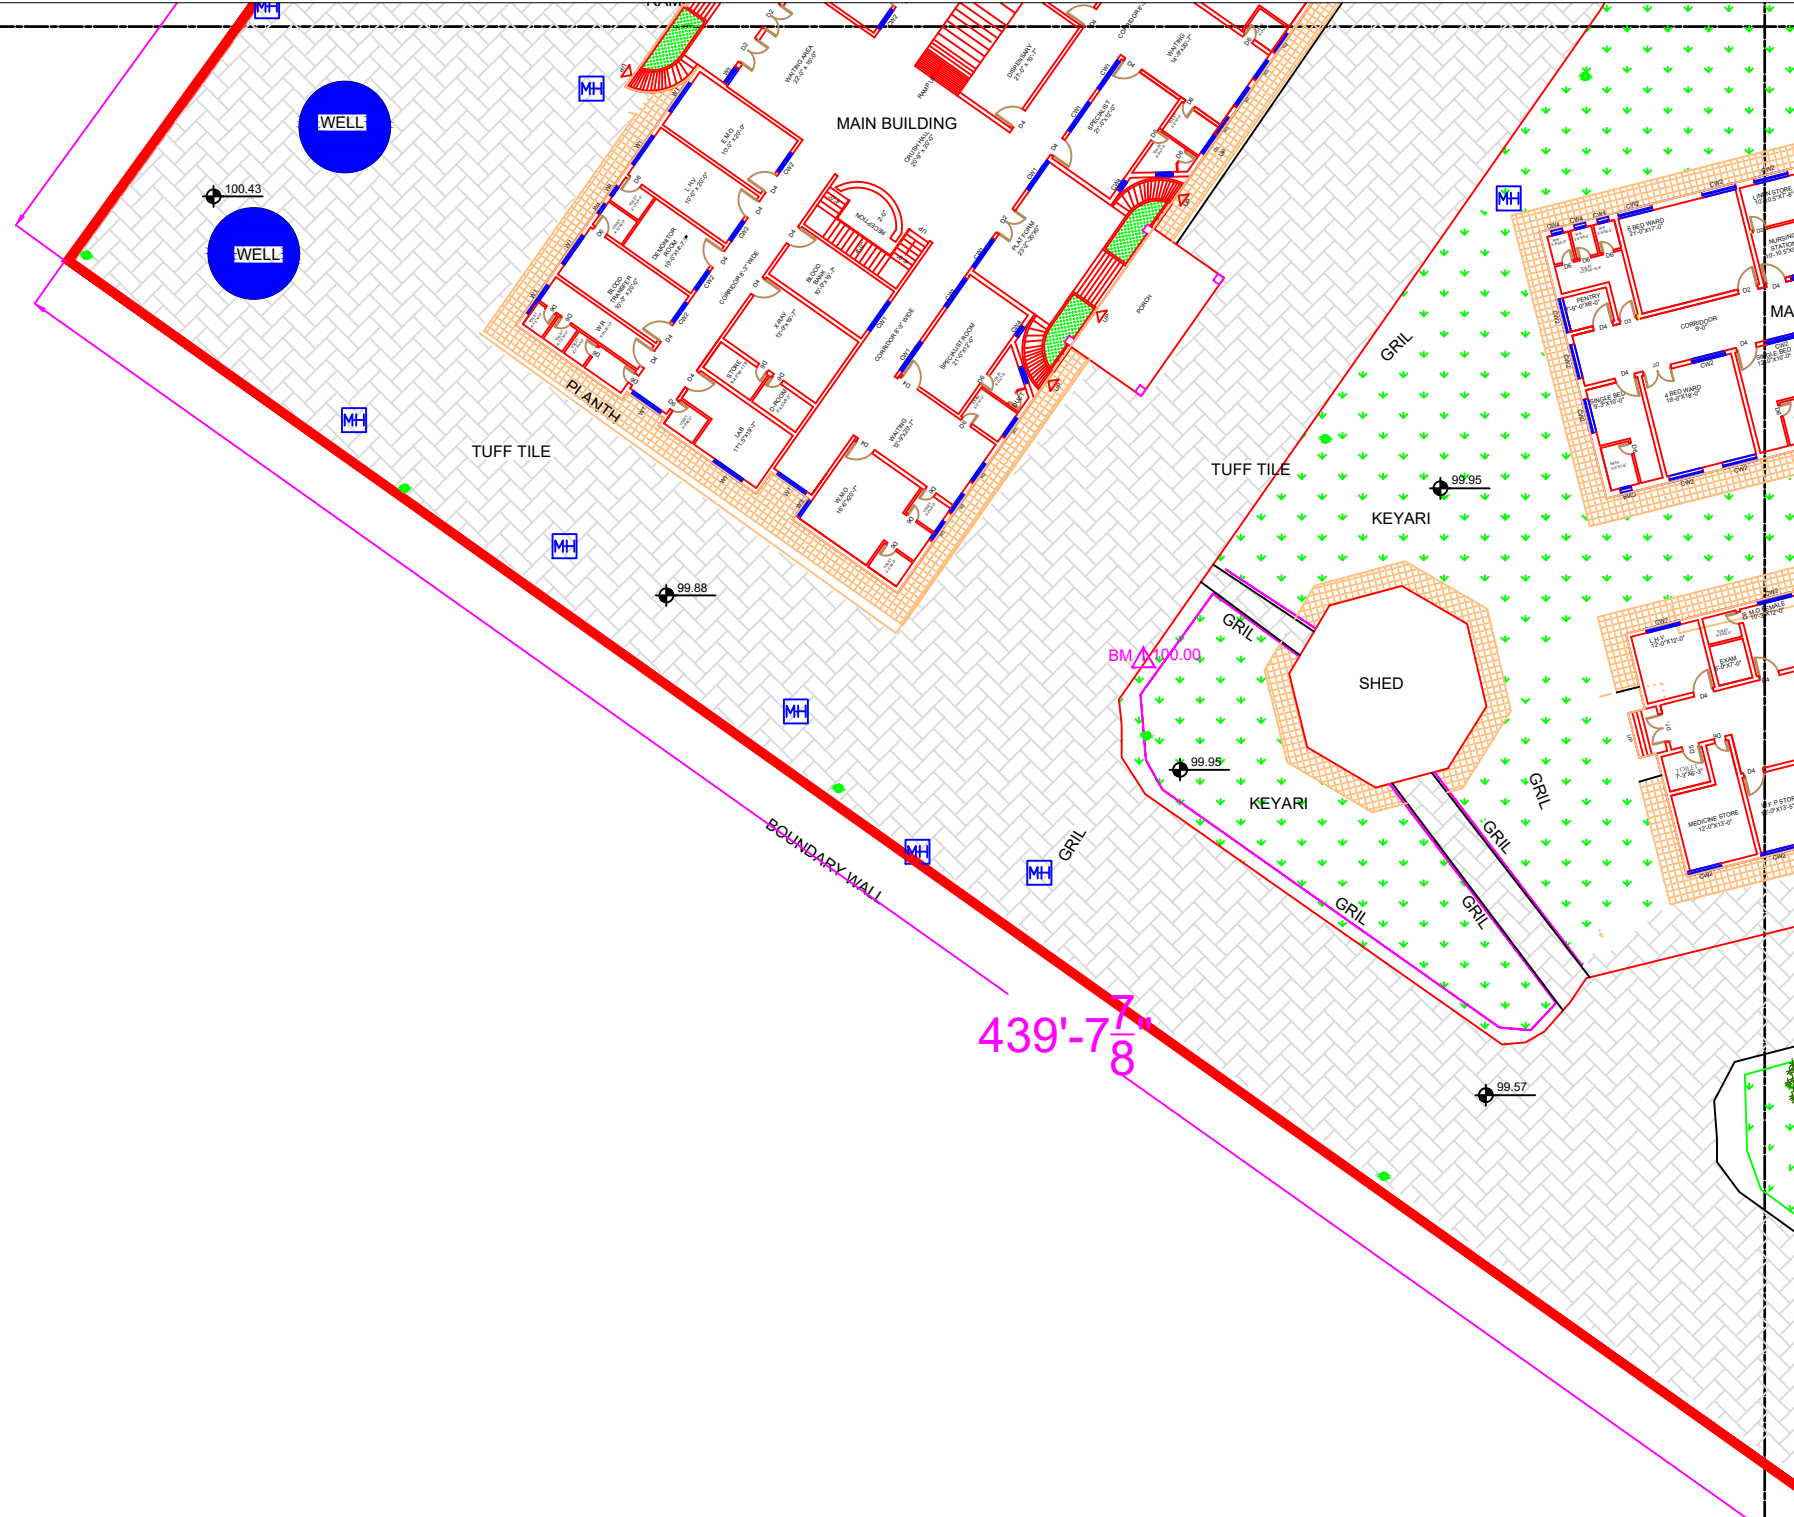


Legends:

Residential Area	
Road	
Wall	
Power Line	
OHT	
Tree	
Man Hole	
Tube Well	
Light Pole	
Lawns	
Earthen Areas	
Asphalts Roads	
Tough Pavers	
P.C.C / Plinth Protection	
Boundary Wall	
Brick Pavers / Soling	
Drain	
Tap	
Hand Pump	
Air Conditioner	
Tube Light	
Fan	
Roof Light	
Bulb	

AREA	
AREA WITHIN BOUNDARY WALL	190422.658 Sft
AREA OF CLINICAL BLOCK	30693.85 Sft
PLINTH AREA OF BLOCK	19836.813 Sft

OPENING SCHEDULE OF DOORS AND WINDOWS					
DOORS	WIDTH	HEIGHT	WINDOWS	WIDTH	HEIGHT
D2	5'-0"	7'-0"	W1	6'-0"	6'-0"
D4	3'-6"	7'-0"	W2	4'-0"	4'-0"
D5	3'-0"	7'-0"	W3	3'-6"	3'-6"
D6	2'-6"	7'-0"	W4	2'-0"	2'-0"

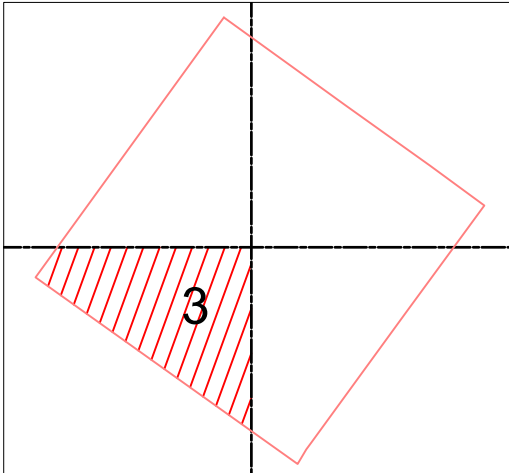

Project: **CAD MAPPING OF TEHSIL HEAD QUARTER HOSPITALS, PUNJAB**

Client: GOVERNMENT OF THE PUNJAB
PRIMARY & SECONDARY HEALTHCARE DEPARTMENT

Consultant: SKAFS CONSULTANT (Pvt.) Limited
ENGINEERING AND ENVIRONMENT CONSULTANT

Drawing Title: **THQ LALLIAN HOSPITAL MASTER PLAN PART 3**

Drawing No. **SKAFS/LALLIAN /06**

MASTER PLAN OF THQ HOSPITAL LALLIAN

PART 4




Legends:

Residential Area	
Road	
Wall	
Power Line	
OHT	
Tree	
Man Hole	
Tube Well	
Light Pole	
Lawns	
Earthen Areas	
Asphalts Roads	
Tough Pavers	
P.C.C / Plinth Protection	
Boundary Wall	
Brick Pavers / Soling	
Drain	
Tap	
Hand Pump	
Air Conditioner	
Tube Light	
Fan	
Roof Light	
Bulb	

AREA	
AREA WITHIN BOUNDARY WALL	190422.658 Sft
AREA OF CLINICAL BLOCK	30693.85 Sft
PLINTH AREA OF BLOCK	19836.813 Sft

OPENING SCHEDULE OF DOORS AND WINDOWS					
DOORS	WIDTH	HEIGHT	WINDOWS	WIDTH	HEIGHT
D2	5'-0"	7'-0"	W1	6'-0"	6'-0"
D4	3'-6"	7'-0"	W2	4'-0"	4'-0"
D5	3'-0"	7'-0"	W3	3'-6"	3'-6"
D6	2'-6"	7'-0"	W4	2'-0"	2'-0"

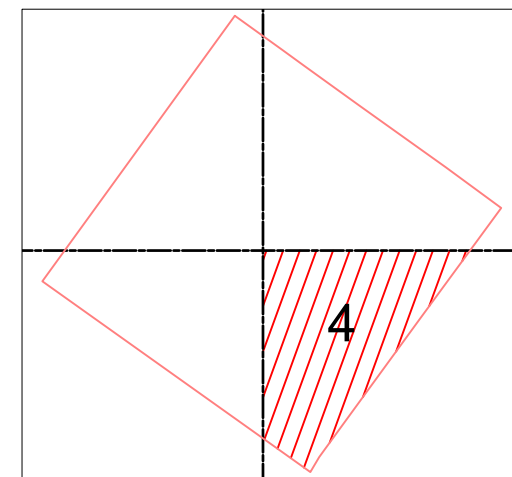

Project:
**CAD MAPPING OF TEHSIL
HEAD QUARTER HOSPITALS,
PUNJAB**

Client: GOVERNMENT OF THE PUNJAB
PRIMARY & SECONDARY
HEALTHCARE DEPARTMENT



Consultant: SKAFS CONSULTANT (Pvt.)
Limited
ENGINEERING AND ENVIRONMENT
CONSULTANT

Drawing Title: **THQ LALLIAN
HOSPITAL MASTER PLAN PART 4**

Drawing No. **SKAFS/LALLIAN /07**



CLINICAL BLOCK OF THQ HOSPITAL LALLIAN GROUND FLOOR

PART 1

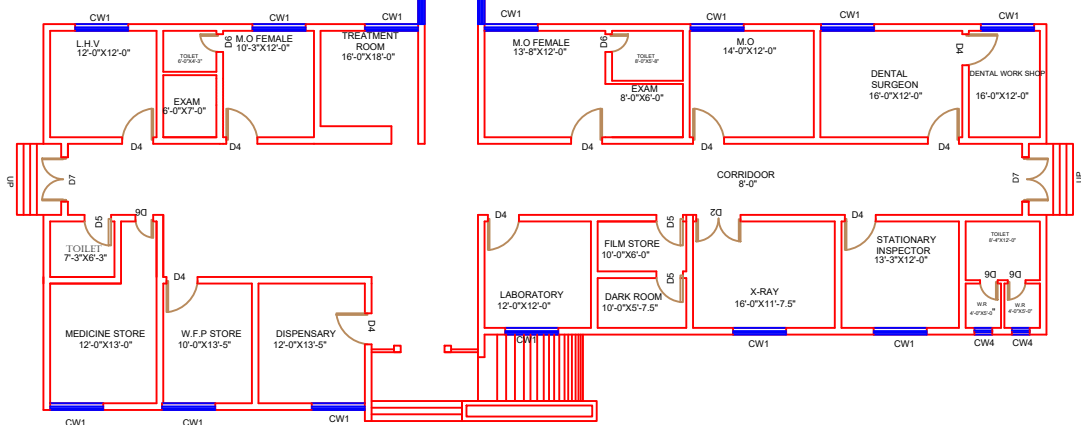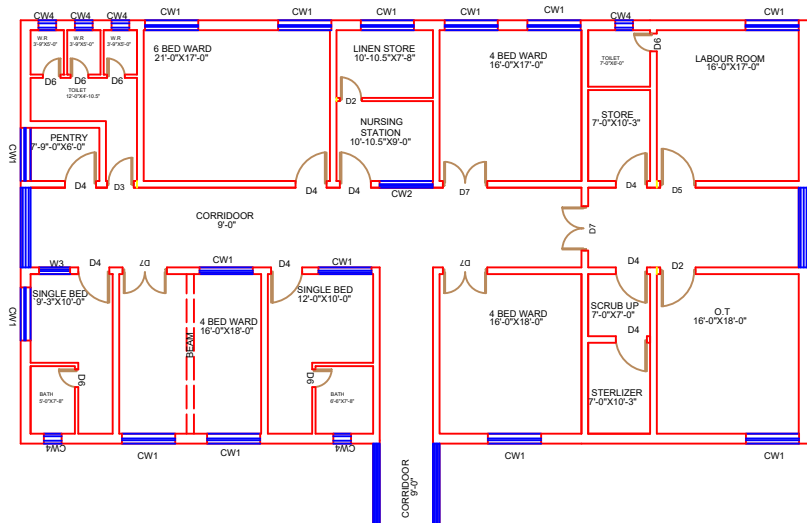

PART 2

PART 3

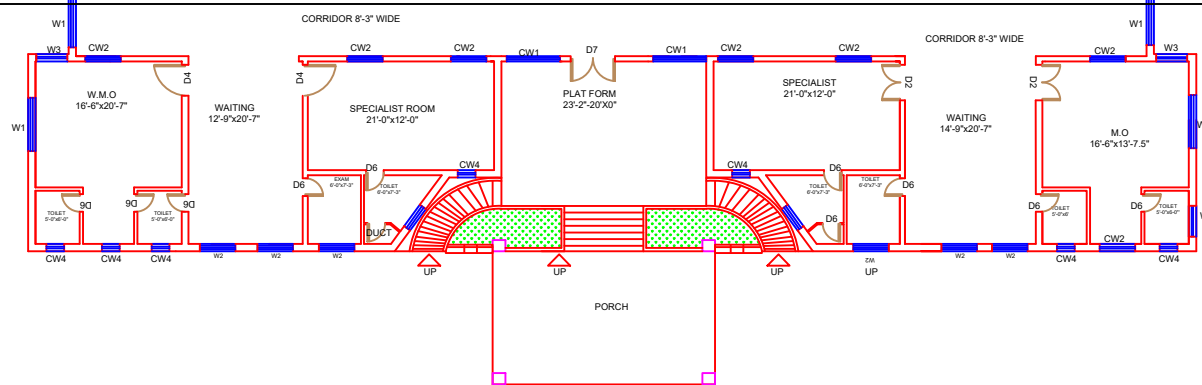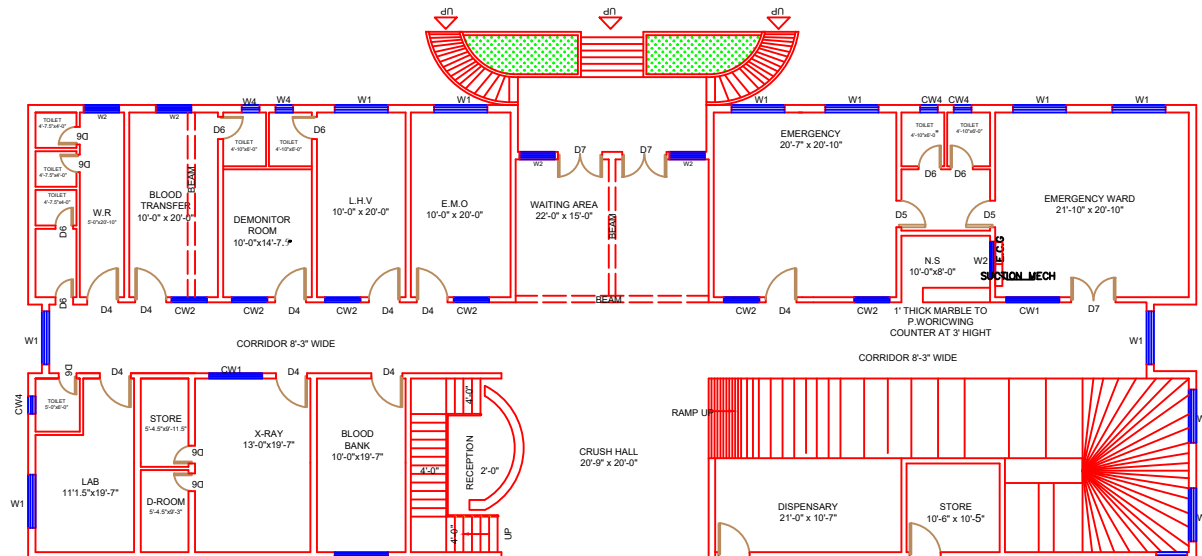

PART 4

Legends:

Residential Area	
Road	
Wall	
Power Line	
OHT	
Tree	
Man Hole	
Tube Well	
Light Pole	
Lawns	
Earthen Areas	
Asphalts Roads	
Tough Pavers	
P.C.C / Plinth Protection	
Boundary Wall	
Brick Pavers / Soling	
Drain	
Tap	
Hand Pump	
Air Conditioner	
Tube Light	
Fan	
Roof Light	
Bulb	

AREA	
AREA WITHIN BOUNDARY WALL	190422.658 Sft
AREA OF CLINICAL BLOCK	30693.85 Sft
PLINTH AREA OF BLOCK	19836.813 Sft

OPENING SCHEDULE OF DOORS AND WINDOWS					
DOORS	WIDTH	HEIGHT	WINDOWS	WIDTH	HEIGHT
D2	5'-0"	7'-0"	W1	6'-0"	6'-0"
D4	3'-6"	7'-0"	W2	4'-0"	4'-0"
D5	3'-0"	7'-0"	W3	3'-6"	3'-6"
D6	2'-6"	7'-0"	W4	2'-0"	2'-0"

Project:
**CAD MAPPING OF TEHSIL
HEAD QUARTER HOSPITALS,
PUNJAB**

Client:
GOVERNMENT OF THE PUNJAB
PRIMARY & SECONDARY
HEALTHCARE DEPARTMENT


Consultant:
SKAFS CONSULTANT (Pvt.)
Limited
ENGINEERING AND ENVIRONMENT
CONSULTANT

Drawing Title:
**THQ LALLIAN
HOSPITAL CLINICAL BLOCK PLAN**

Drawing No.
SKAFS/LALLIAN /08

CLINICAL BLOCK OF THQ HOSPITAL LALLIAN

GROUND FLOOR PART 1

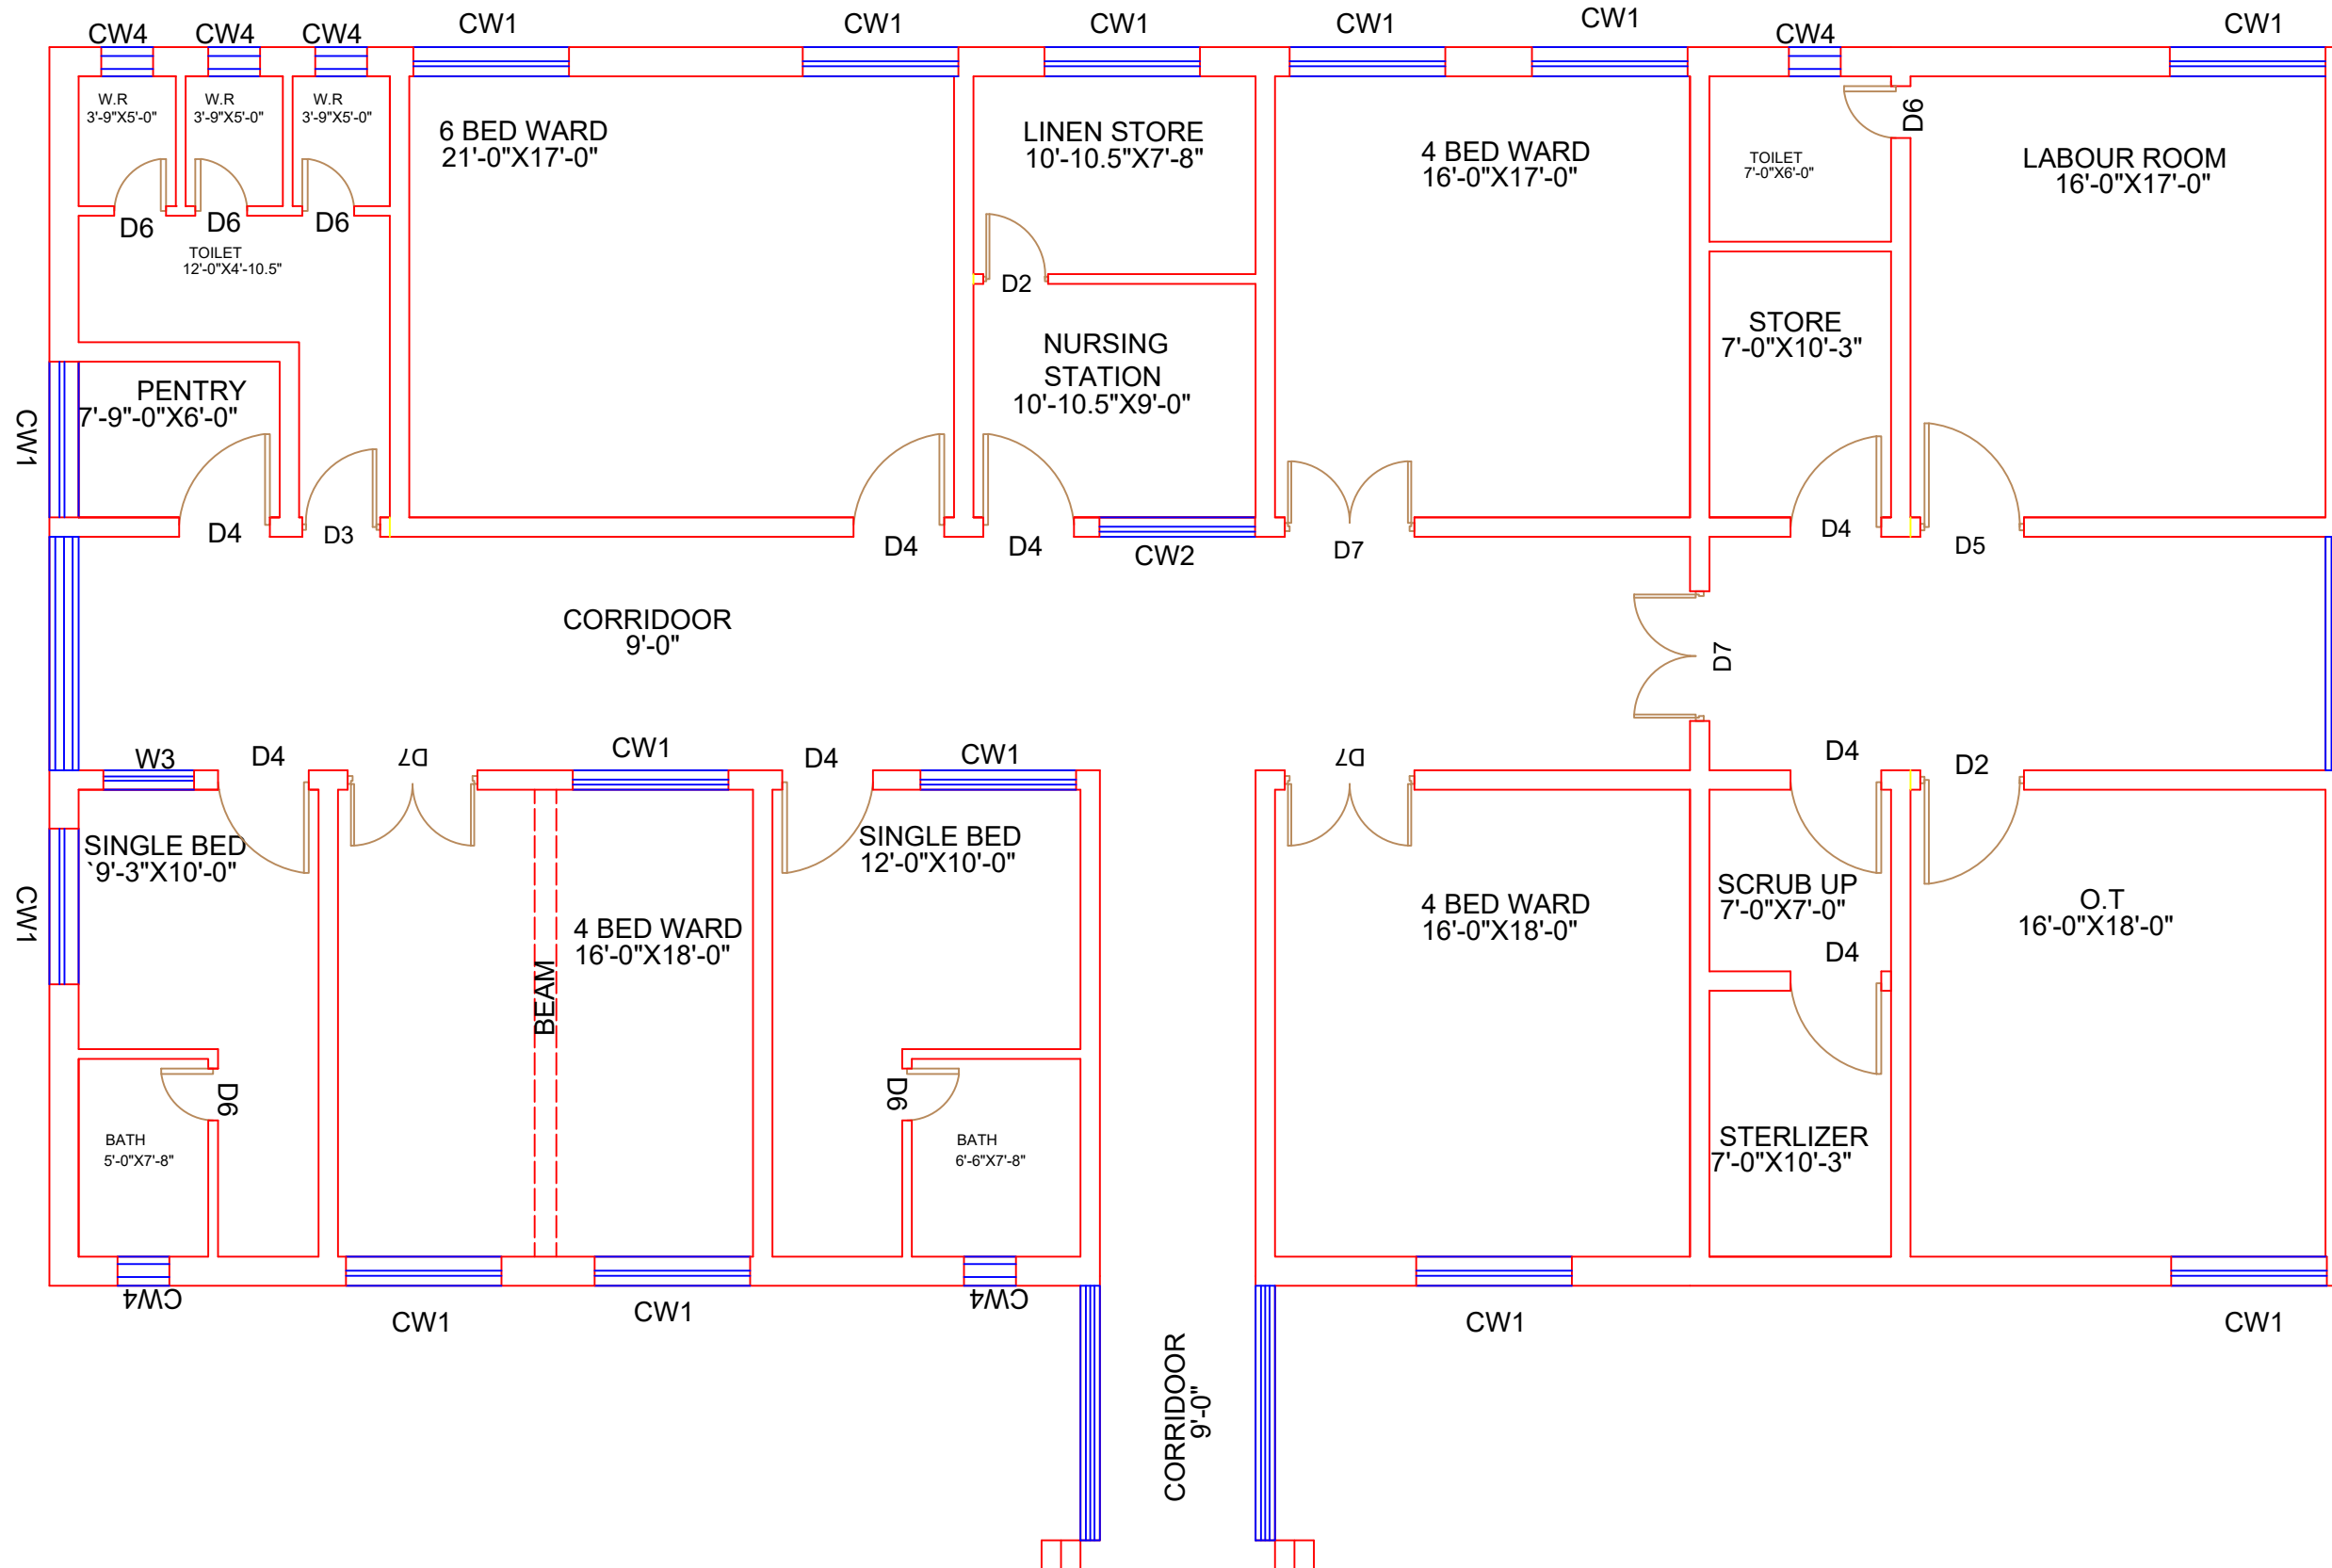

Legends:

Residential Area	
Road	
Wall	
Power Line	
OHT	
Tree	
Man Hole	
Tube Well	
Light Pole	
Lawns	
Earthen Areas	
Asphalts Roads	
Tough Pavers	
P.C.C / Plinth Protection	
Boundary Wall	
Brick Pavers / Soling	
Drain	
Tap	
Hand Pump	
Air Conditioner	
Tube Light	
Fan	
Roof Light	
Bulb	

AREA	
AREA WITHIN BOUNDARY WALL	190422.658 Sft
AREA OF CLINICAL BLOCK	30693.85 Sft
PLINTH AREA OF BLOCK	19836.813 Sft

OPENING SCHEDULE OF DOORS AND WINDOWS					
DOORS	WIDTH	HEIGHT	WINDOWS	WIDTH	HEIGHT
D2	5'-0"	7'-0"	W1	6'-0"	6'-0"
D4	3'-6"	7'-0"	W2	4'-0"	4'-0"
D5	3'-0"	7'-0"	W3	3'-6"	3'-6"
D6	2'-6"	7'-0"	W4	2'-0"	2'-0"

Project:
CAD MAPPING OF TEHSIL HEAD QUARTER HOSPITALS, PUNJAB

Client: GOVERNMENT OF THE PUNJAB
 PRIMARY & SECONDARY HEALTHCARE DEPARTMENT


Consultant: SKAFS CONSULTANT (Pvt.) Limited
 ENGINEERING AND ENVIRONMENT CONSULTANT

Drawing Title: **THQ LALLIAN CLINICAL BLOCK PLAN (PART 1)**

Drawing No. **SKAFS/LALLIAN /09**

CLINICAL BLOCK OF THQ HOSPITAL LALLIAN

GROUND FLOOR PART 2

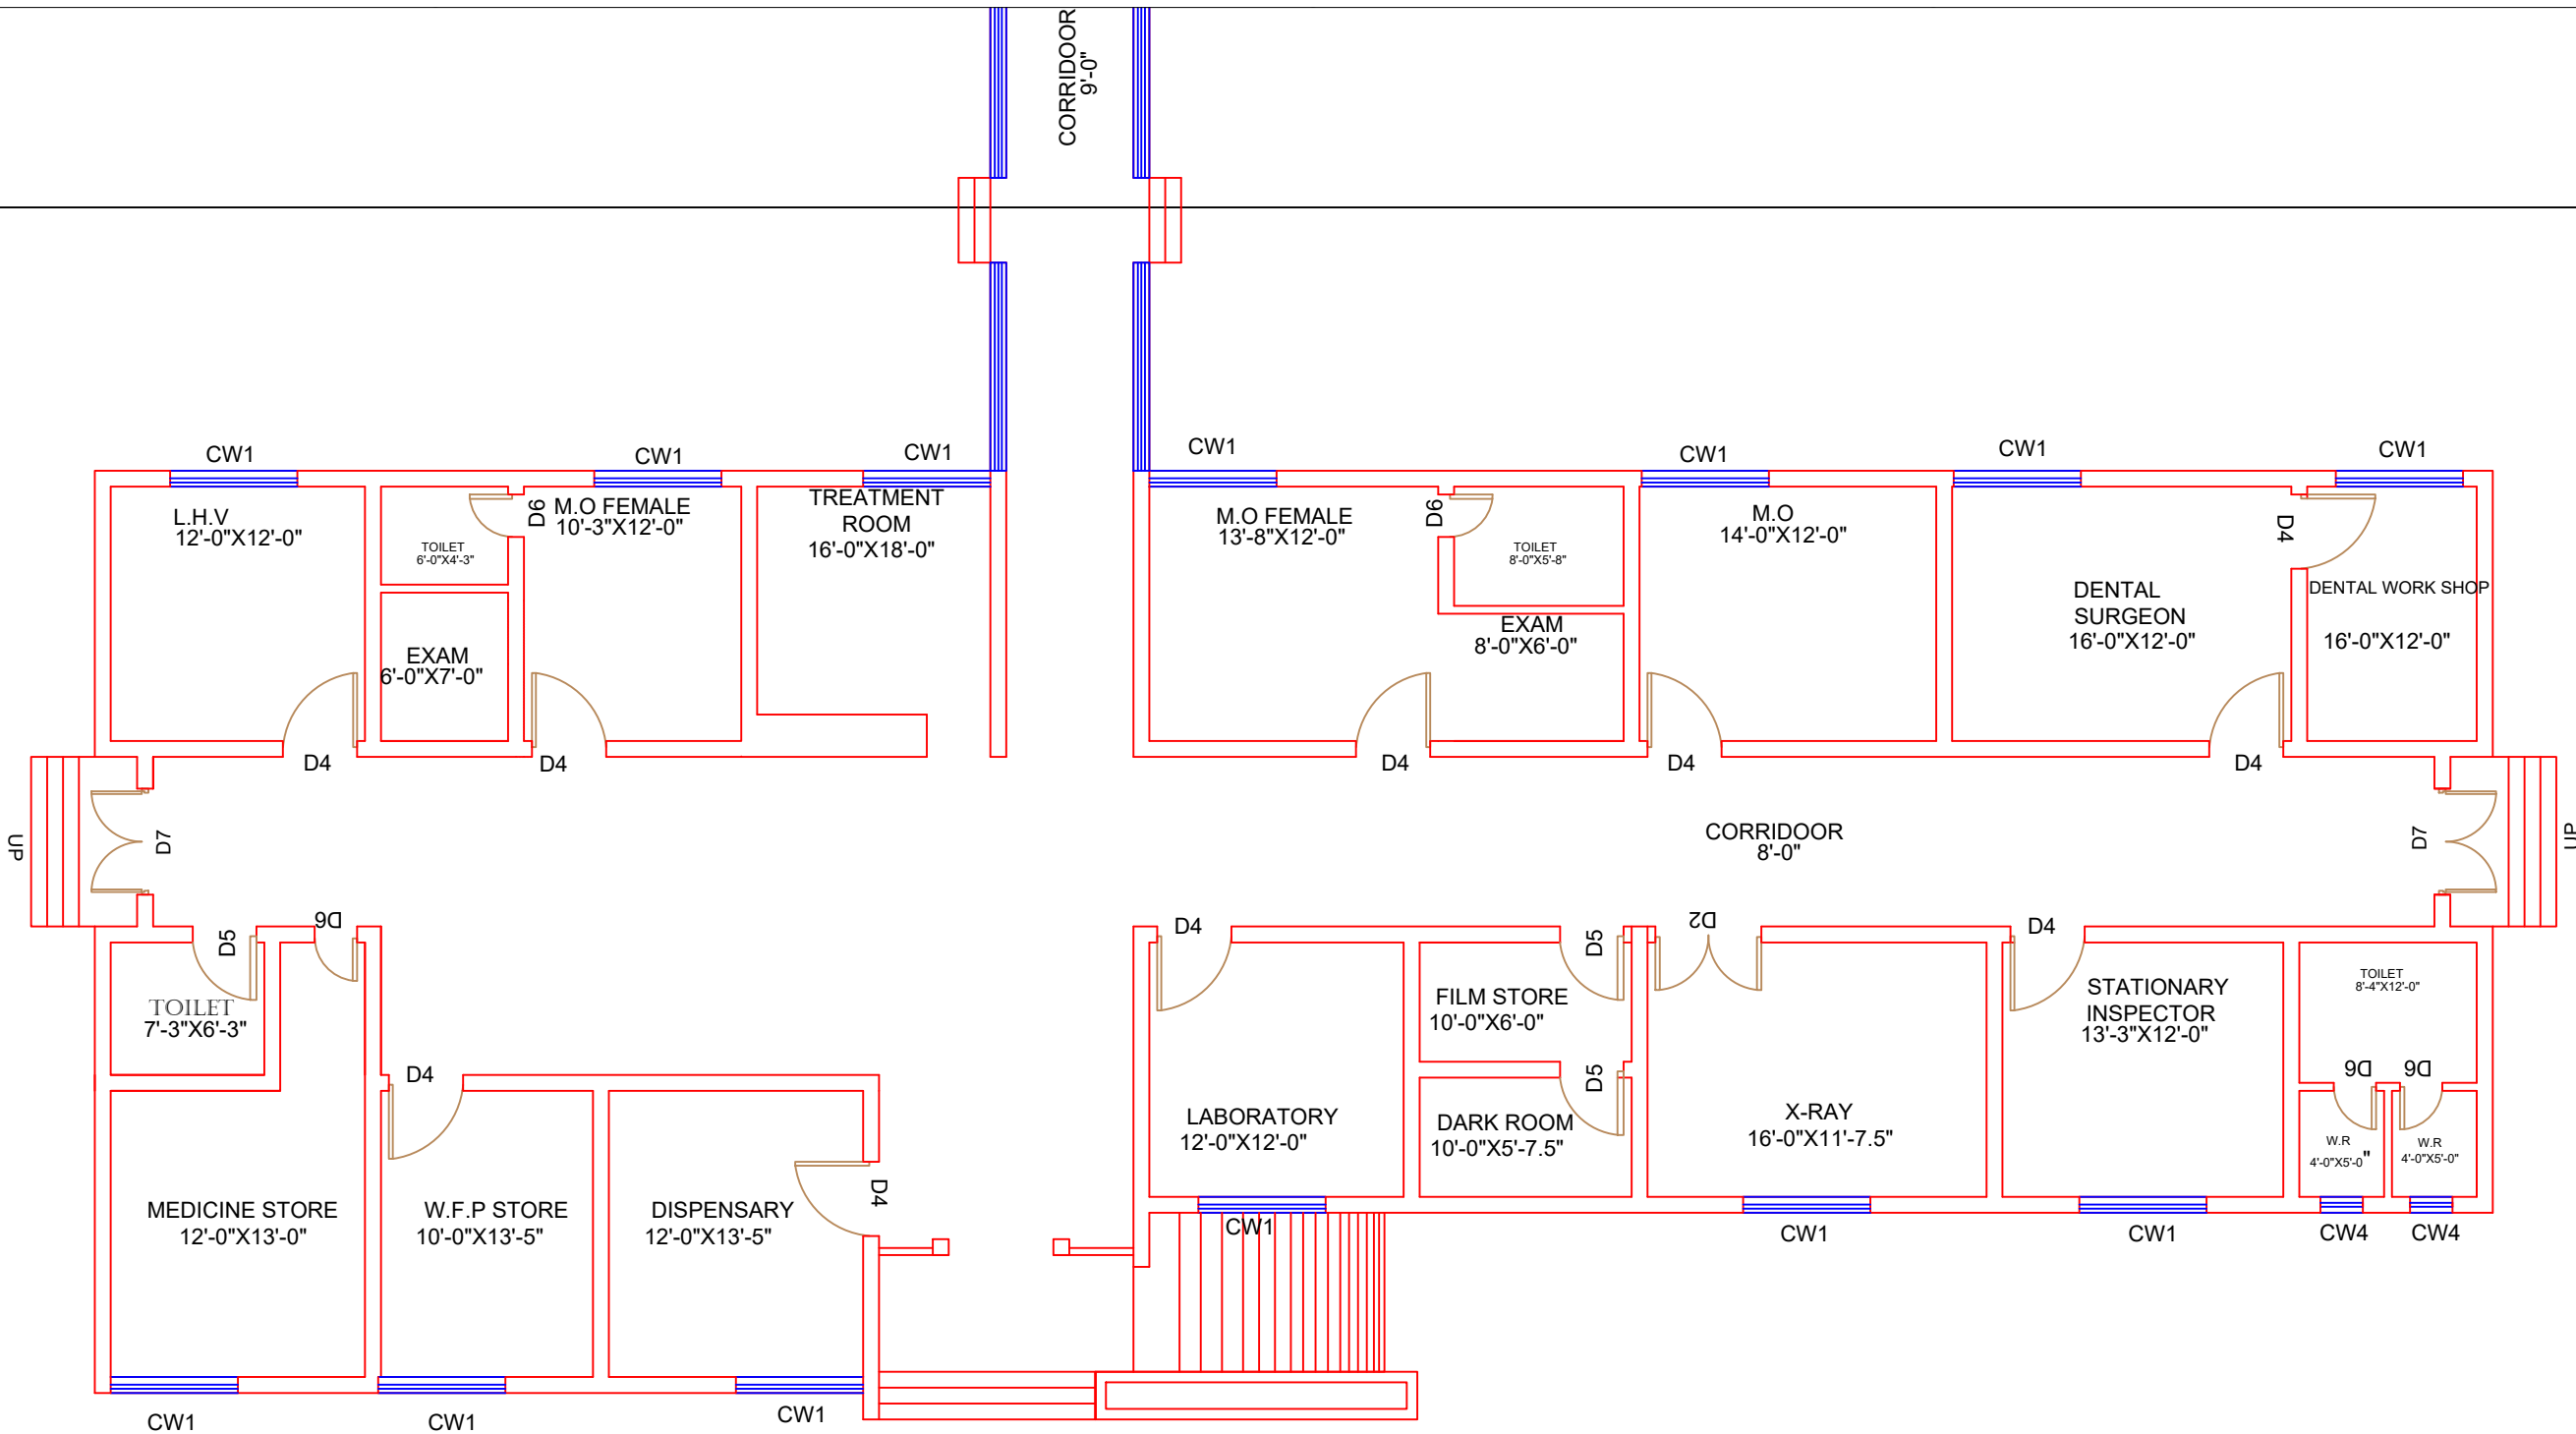

Legends:

Residential Area	
Road	
Wall	
Power Line	
OHT	
Tree	
Man Hole	
Tube Well	
Light Pole	
Lawns	
Earthen Areas	
Asphalts Roads	
Tough Pavers	
P.C.C / Plinth Protection	
Boundary Wall	
Brick Pavers / Soling	
Drain	
Tap	
Hand Pump	
Air Conditioner	
Tube Light	
Fan	
Roof Light	
Bulb	

AREA	
AREA WITHIN BOUNDARY WALL	190422.658 Sft
AREA OF CLINICAL BLOCK	30693.85 Sft
PLINTH AREA OF BLOCK	19836.813 Sft

OPENING SCHEDULE OF DOORS AND WINDOWS					
DOORS	WIDTH	HEIGHT	WINDOWS	WIDTH	HEIGHT
D2	5'-0"	7'-0"	W1	6'-0"	6'-0"
D4	3'-6"	7'-0"	W2	4'-0"	4'-0"
D5	3'-0"	7'-0"	W3	3'-6"	3'-6"
D6	2'-6"	7'-0"	W4	2'-0"	2'-0"

Project:
CAD MAPPING OF TEHSIL HEAD QUARTER HOSPITALS, PUNJAB

Client: GOVERNMENT OF THE PUNJAB PRIMARY & SECONDARY HEALTHCARE DEPARTMENT	Consultant: SKAFS CONSULTANT (Pvt.) Limited ENGINEERING AND ENVIRONMENT CONSULTANT
---	--

Drawing Title:
THQ LALLIAN CLINICAL BLOCK PLAN (PART 2)


Drawing No. **SKAFS/LALLIAN /10**

CLINICAL BLOCK OF THQ HOSPITAL LALLIAN

GROUND FLOOR PART 3

Legends:

Residential Area	
Road	
Wall	
Power Line	
OHT	
Tree	
Man Hole	
Tube Well	
Light Pole	
Lawns	
Earthen Areas	
Asphalts Roads	
Tough Pavers	
P.C.C / Plinth Protection	
Boundary Wall	
Brick Pavers / Soling	
Drain	
Tap	
Hand Pump	
Air Conditioner	
Tube Light	
Fan	
Roof Light	
Bulb	

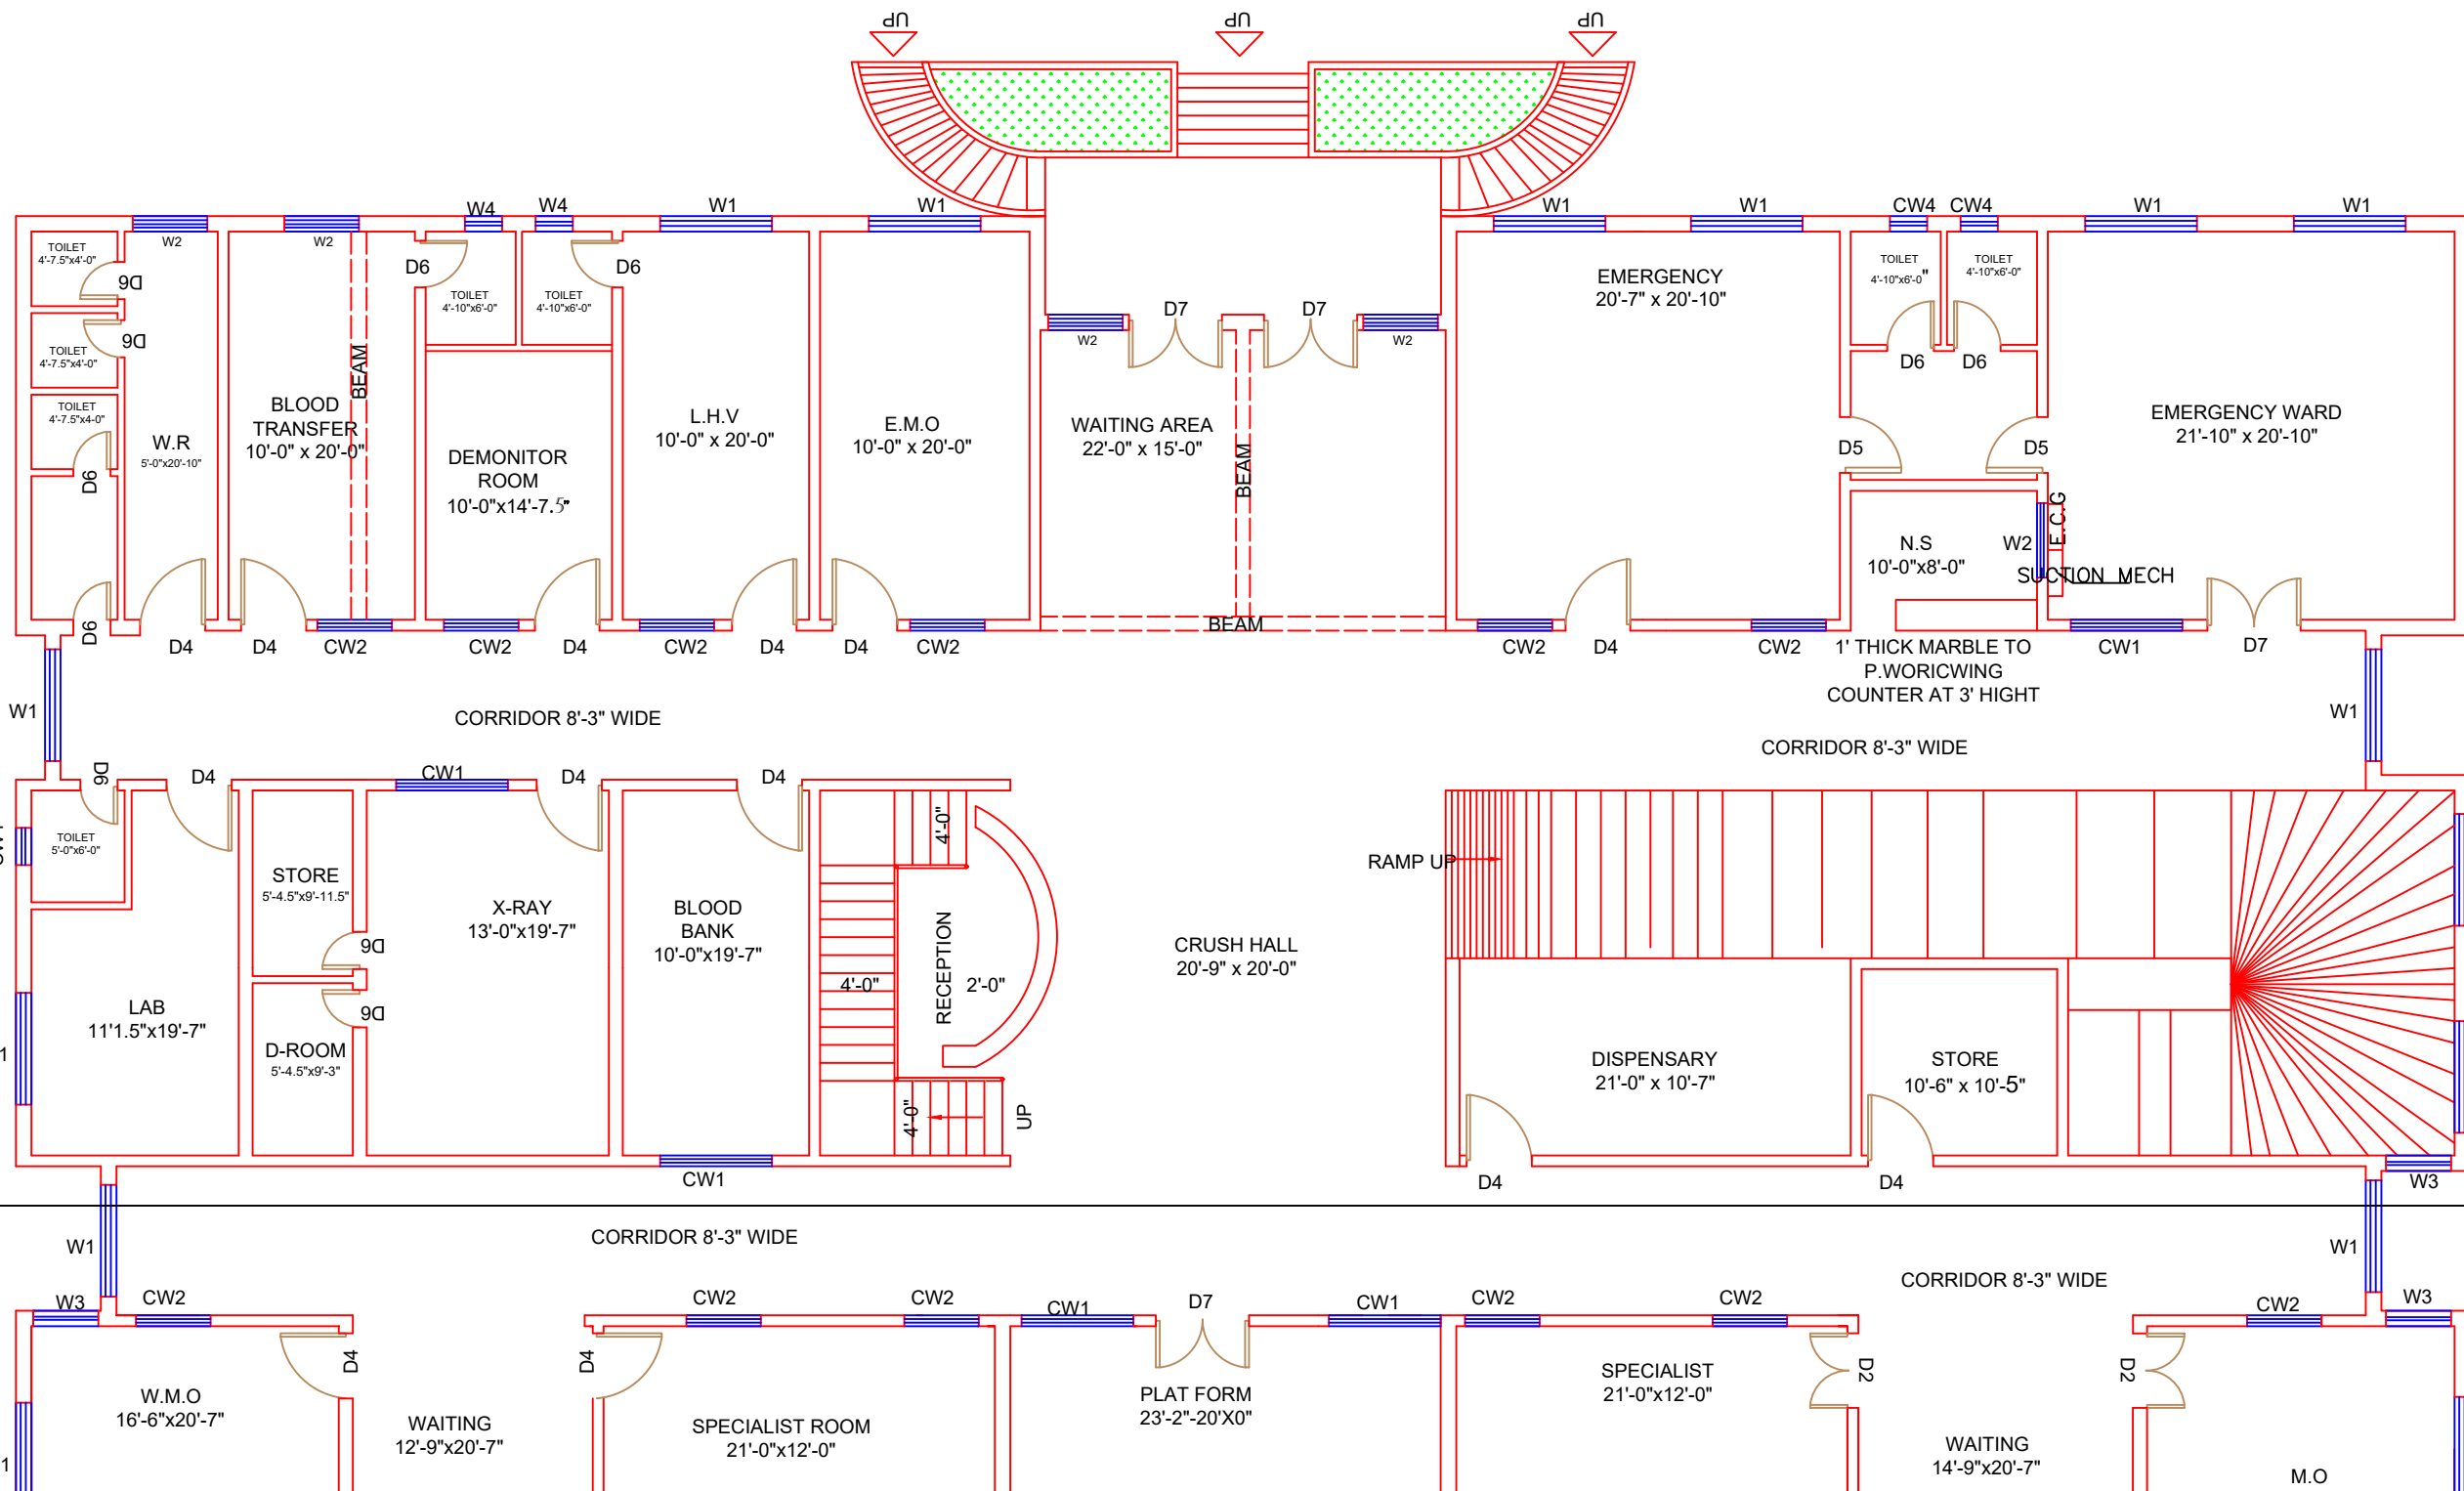

AREA	
AREA WITHIN BOUNDARY WALL	190422.658 Sft
AREA OF CLINICAL BLOCK	30693.85 Sft
PLINTH AREA OF BLOCK	19836.813 Sft

OPENING SCHEDULE OF DOORS AND WINDOWS					
DOORS	WIDTH	HEIGHT	WINDOWS	WIDTH	HEIGHT
D2	5'-0"	7'-0"	W1	6'-0"	6'-0"
D4	3'-6"	7'-0"	W2	4'-0"	4'-0"
D5	3'-0"	7'-0"	W3	3'-6"	3'-6"
D6	2'-6"	7'-0"	W4	2'-0"	2'-0"

Project:
CAD MAPPING OF TEHSIL HEAD QUARTER HOSPITALS, PUNJAB


Client: GOVERNMENT OF THE PUNJAB PRIMARY & SECONDARY HEALTHCARE DEPARTMENT	Consultant: SKAFS CONSULTANT (Pvt.) Limited ENGINEERING AND ENVIRONMENT CONSULTANT
---	--

Drawing Title:
THQ LALLIAN CLINICAL BLOCK PLAN (PART 3)

Drawing No.
SKAFS/LALLIAN /11

CLINICAL BLOCK OF THQ HOSPITAL LALLIAN

GROUND FLOOR PART 4

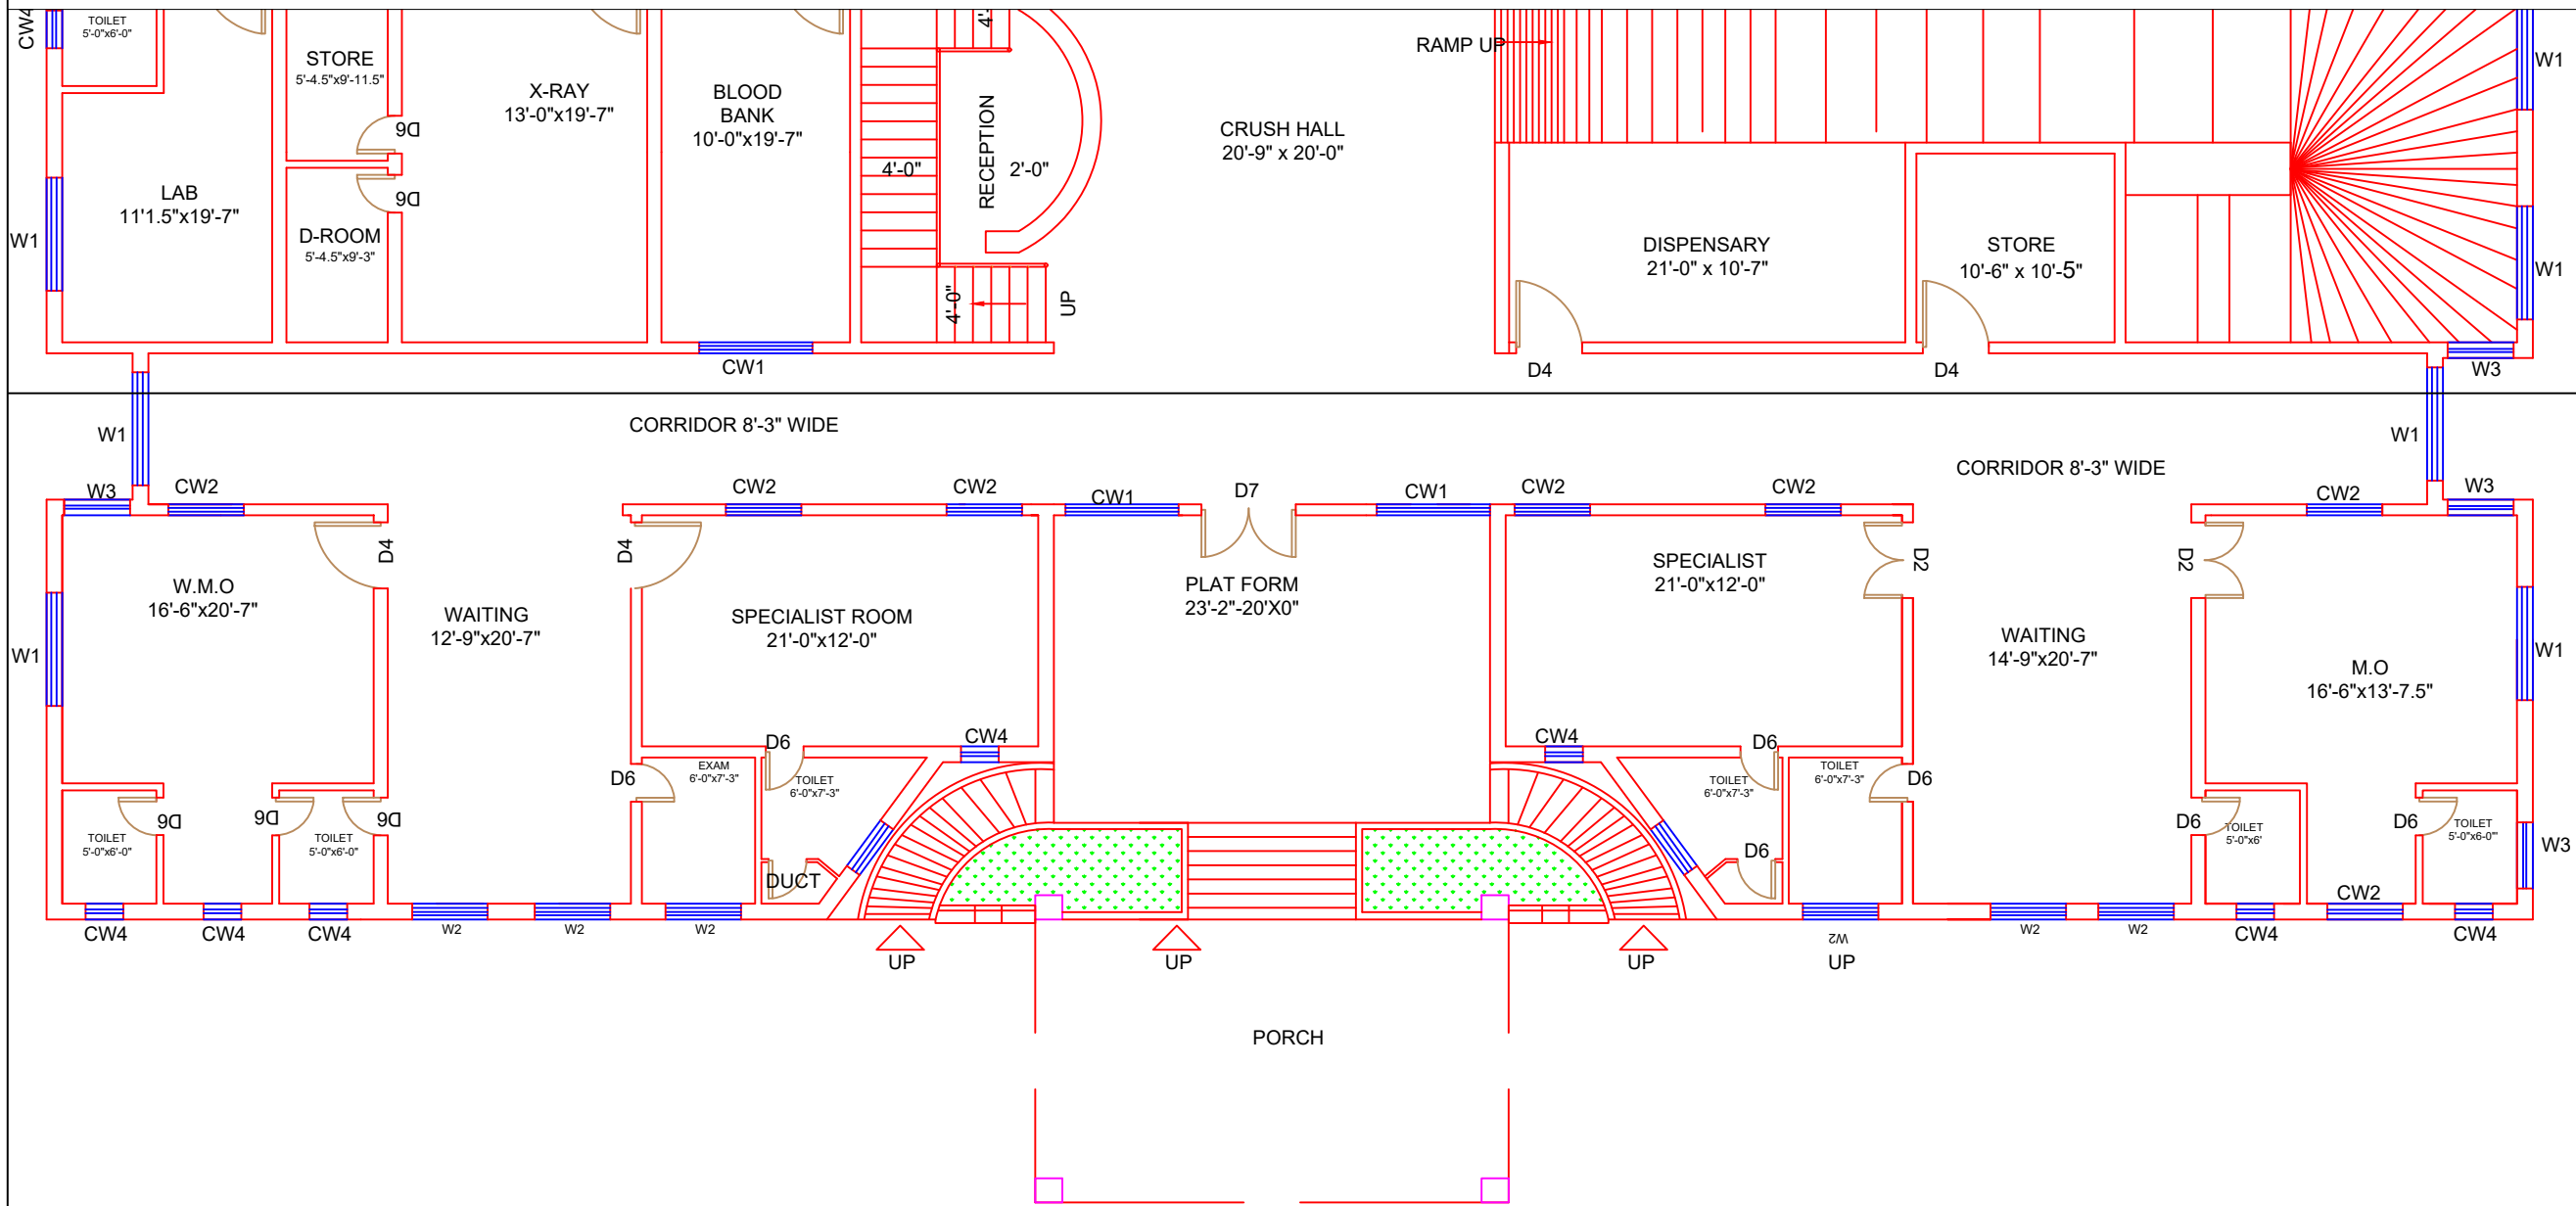

Legends:

Residential Area	
Road	
Wall	
Power Line	
OHT	
Tree	
Man Hole	
Tube Well	
Light Pole	
Lawns	
Earthen Areas	
Asphalts Roads	
Tough Pavers	
P.C.C / Plinth Protection	
Boundary Wall	
Brick Pavers / Soling	
Drain	
Tap	
Hand Pump	
Air Conditioner	
Tube Light	
Fan	
Roof Light	
Bulb	

AREA	
AREA WITHIN BOUNDARY WALL	190422.658 Sft
AREA OF CLINICAL BLOCK	30693.85 Sft
PLINTH AREA OF BLOCK	19836.813 Sft

OPENING SCHEDULE OF DOORS AND WINDOWS					
DOORS	WIDTH	HEIGHT	WINDOWS	WIDTH	HEIGHT
D2	5'-0"	7'-0"	W1	6'-0"	6'-0"
D4	3'-6"	7'-0"	W2	4'-0"	4'-0"
D5	3'-0"	7'-0"	W3	3'-6"	3'-6"
D6	2'-6"	7'-0"	W4	2'-0"	2'-0"


Project:
CAD MAPPING OF TEHSIL HEAD QUARTER HOSPITALS, PUNJAB

Client: GOVERNMENT OF THE PUNJAB PRIMARY & SECONDARY HEALTHCARE DEPARTMENT	Consultant: SKAFS CONSULTANT (Pvt.) Limited ENGINEERING AND ENVIRONMENT CONSULTANT
---	--

Drawing Title:
THQ LALLIAN CLINICAL BLOCK PLAN (PART 4)

CLINICAL BLOCK OF THQ HOSPITAL LALLIAN

FIRST FLOOR PART 1

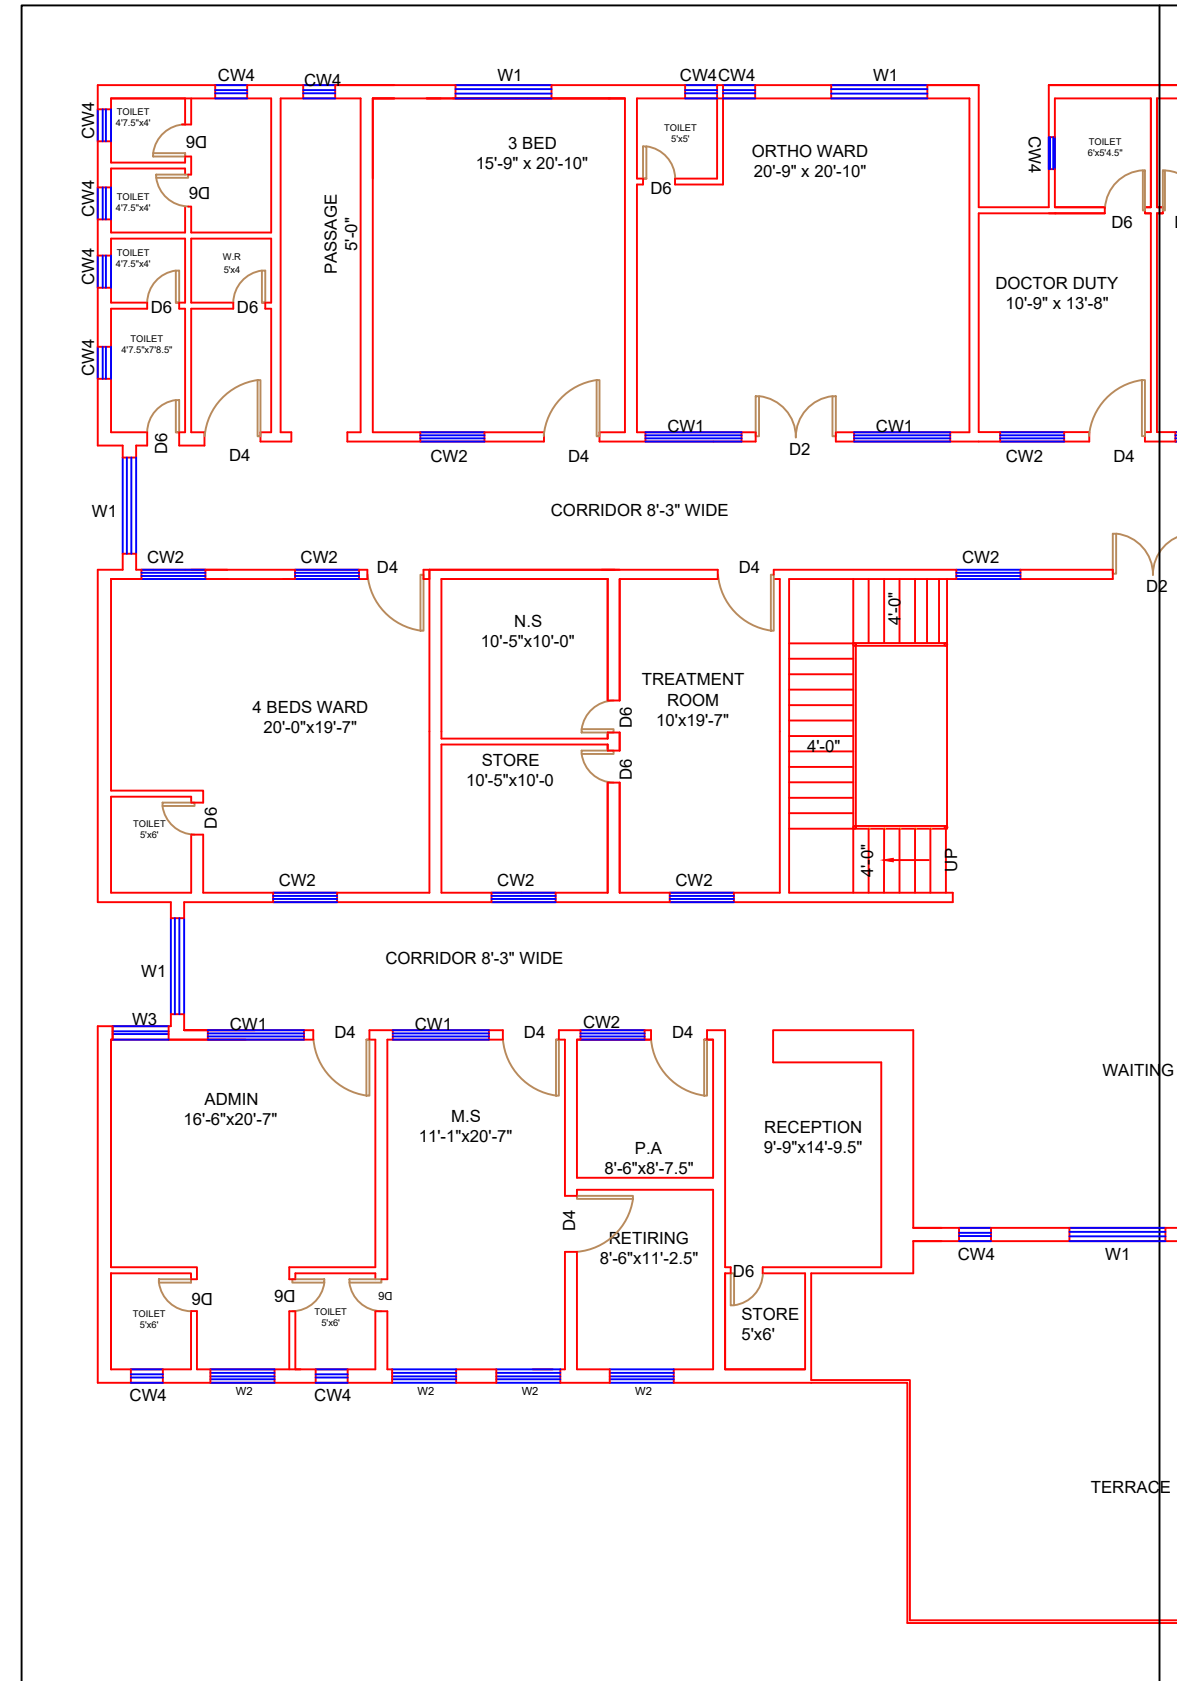

Legends:

Residential Area	
Road	
Wall	
Power Line	
OHT	
Tree	
Man Hole	
Tube Well	
Light Pole	
Lawns	
Earthen Areas	
Asphalts Roads	
Tough Pavers	
P.C.C / Plinth Protection	
Boundary Wall	
Brick Pavers / Soling	
Drain	
Tap	
Hand Pump	
Air Conditioner	
Tube Light	
Fan	
Roof Light	
Bulb	

AREA	
AREA WITHIN BOUNDARY WALL	190422.658 Sft
AREA OF CLINICAL BLOCK	30693.85 Sft
PLINTH AREA OF BLOCK	19836.813 Sft

OPENING SCHEDULE OF DOORS AND WINDOWS					
DOORS	WIDTH	HEIGHT	WINDOWS	WIDTH	HEIGHT
D2	5'-0"	7'-0"	W1	6'-0"	6'-0"
D4	3'-6"	7'-0"	W2	4'-0"	4'-0"
D5	3'-0"	7'-0"	W3	3'-6"	3'-6"
D6	2'-6"	7'-0"	W4	2'-0"	2'-0"

Project:
CAD MAPPING OF TEHSIL HEAD QUARTER HOSPITALS, PUNJAB


Client: GOVERNMENT OF THE PUNJAB PRIMARY & SECONDARY HEALTHCARE DEPARTMENT	Consultant: SKAFS CONSULTANT (Pvt.) Limited ENGINEERING AND ENVIRONMENT CONSULTANT
---	--

Drawing Title:
**THQ LALLIAN
FIRST FLOOR PLAN (PART 1)**

Drawing No. **SKAFS/LALLIAN /13**

CLINICAL BLOCK OF THQ HOSPITAL LALLIAN

FIRST FLOOR PART 2

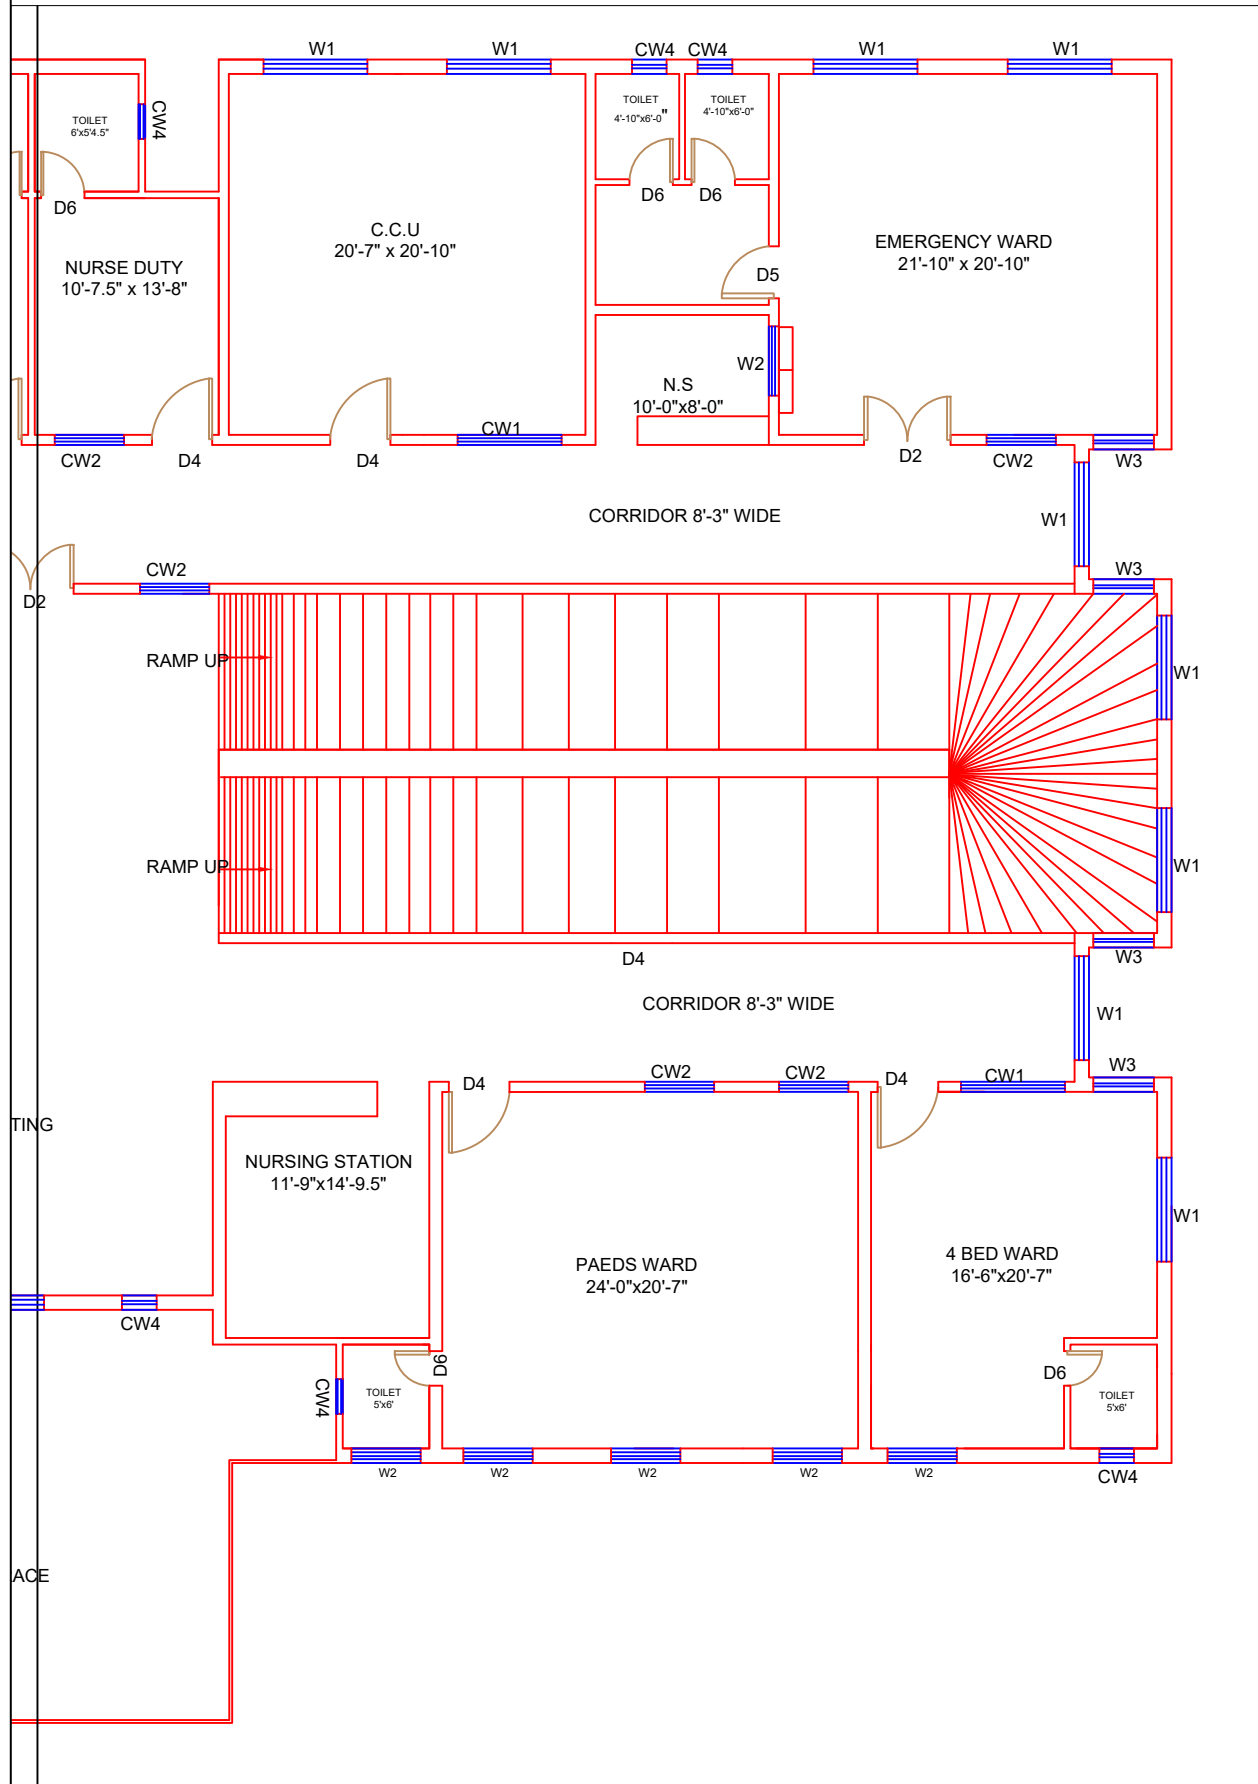

Legends:

Residential Area	
Road	
Wall	
Power Line	
OHT	
Tree	
Man Hole	
Tube Well	
Light Pole	
Lawns	
Earthen Areas	
Asphalts Roads	
Tough Pavers	
P.C.C / Plinth Protection	
Boundary Wall	
Brick Pavers / Soling	
Drain	
Tap	
Hand Pump	
Air Conditioner	
Tube Light	
Fan	
Roof Light	
Bulb	

AREA

AREA WITHIN BOUNDARY WALL	190422.658 Sft
AREA OF CLINICAL BLOCK	30693.85 Sft
PLINTH AREA OF BLOCK	19836.813 Sft

OPENING SCHEDULE OF DOORS AND WINDOWS

DOORS	WIDTH	HEIGHT	WINDOWS	WIDTH	HEIGHT
D2	5'-0"	7'-0"	W1	6'-0"	6'-0"
D4	3'-6"	7'-0"	W2	4'-0"	4'-0"
D5	3'-0"	7'-0"	W3	3'-6"	3'-6"
D6	2'-6"	7'-0"	W4	2'-0"	2'-0"

Project:
CAD MAPPING OF TEHSIL HEAD QUARTER HOSPITALS, PUNJAB


Client: GOVERNMENT OF THE PUNJAB
PRIMARY & SECONDARY HEALTHCARE DEPARTMENT

Consultant: SKAFS CONSULTANT (Pvt.) Limited
ENGINEERING AND ENVIRONMENT CONSULTANT

Drawing Title: **THQ LALLIAN FIRST FLOOR PLAN (PART 2)**

Drawing No. **SKAFS/LALLIAN /14**

ELECTRICAL LAYOUT PLAN OF THQ HOSPITAL LALLIAN GROUND FLOOR

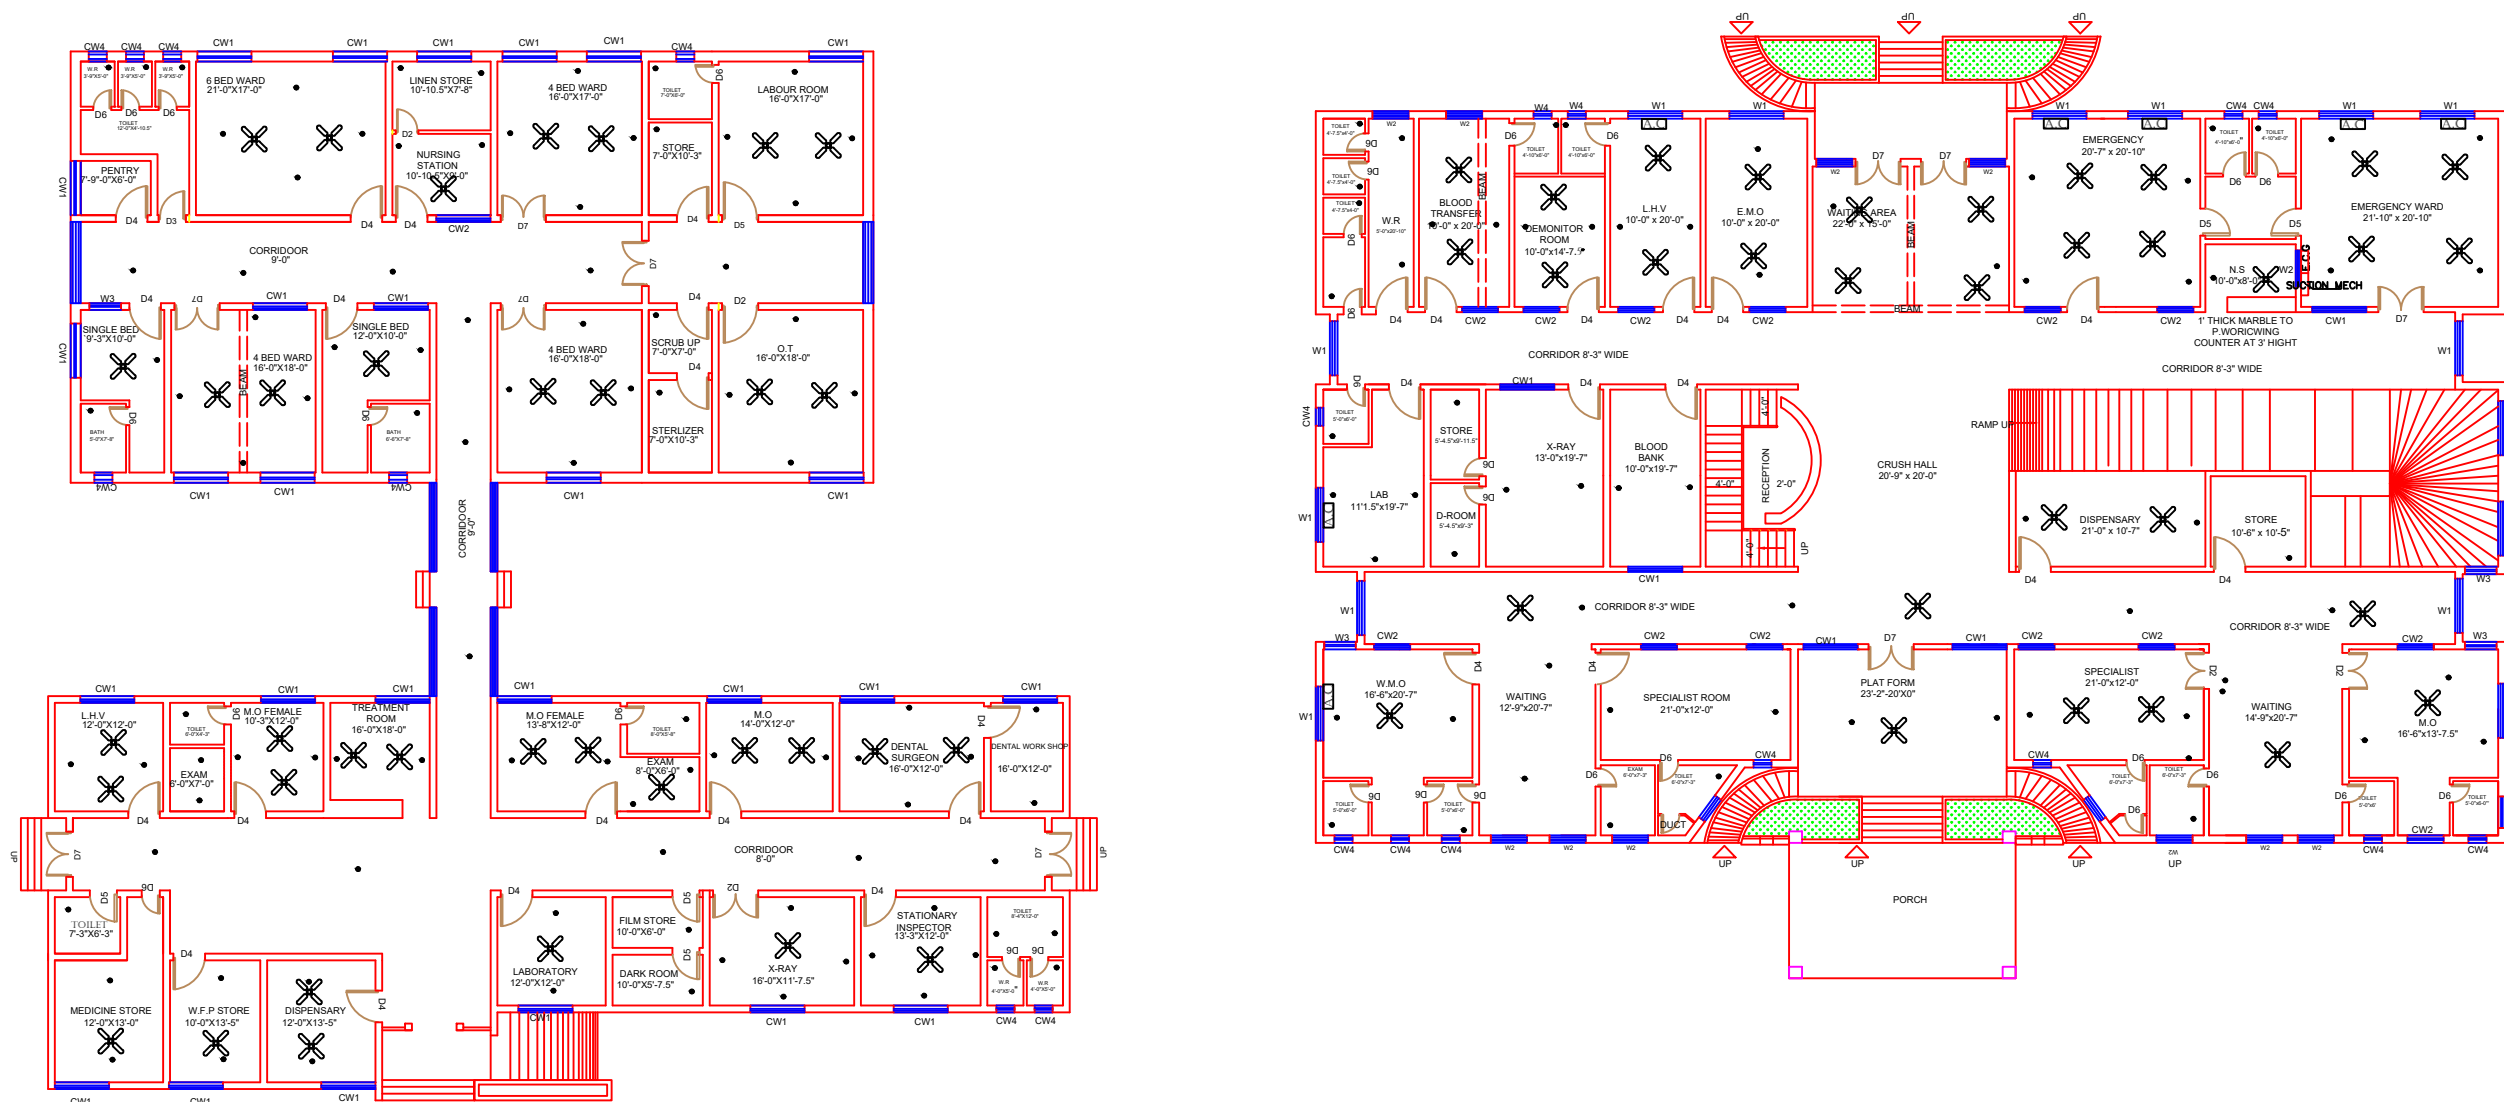

Legends:

Residential Area	
Road	
Wall	
Power Line	
OHT	
Tree	
Man Hole	
Tube Well	
Light Pole	
Lawns	
Earthen Areas	
Asphalts Roads	
Tough Pavers	
P.C.C / Plinth Protection	
Boundary Wall	
Brick Pavers / Soling	
Drain	
Tap	
Hand Pump	
Air Conditioner	
Tube Light	
Fan	
Roof Light	
Bulb	

AREA

AREA WITHIN BOUNDARY WALL	190422.658 Sft
AREA OF CLINICAL BLOCK	30693.85 Sft
PLINTH AREA OF BLOCK	19836.813 Sft

OPENING SCHEDULE OF DOORS AND WINDOWS

DOORS	WIDTH	HEIGHT	WINDOWS	WIDTH	HEIGHT
D2	5'-0"	7'-0"	W1	6'-0"	6'-0"
D4	3'-6"	7'-0"	W2	4'-0"	4'-0"
D5	3'-0"	7'-0"	W3	3'-6"	3'-6"
D6	2'-6"	7'-0"	W4	2'-0"	2'-0"

Project:
**CAD MAPPING OF TEHSIL
HEAD QUARTER HOSPITALS,
PUNJAB**


Client: GOVERNMENT OF THE PUNJAB
PRIMARY & SECONDARY
HEALTHCARE DEPARTMENT

Consultant: SKAFS CONSULTANT (Pvt.)
Limited
ENGINEERING AND ENVIRONMENT
CONSULTANT

Drawing Title: **THQ LALLIAN
ELECTRICAL PLAN (GROUND FLOOR)**

Drawing No. **SKAFS/LALLIAN /15**

ELECTRICAL LAYOUT PLAN OF THQ HOSPITAL LALLIAN FIRST FLOOR

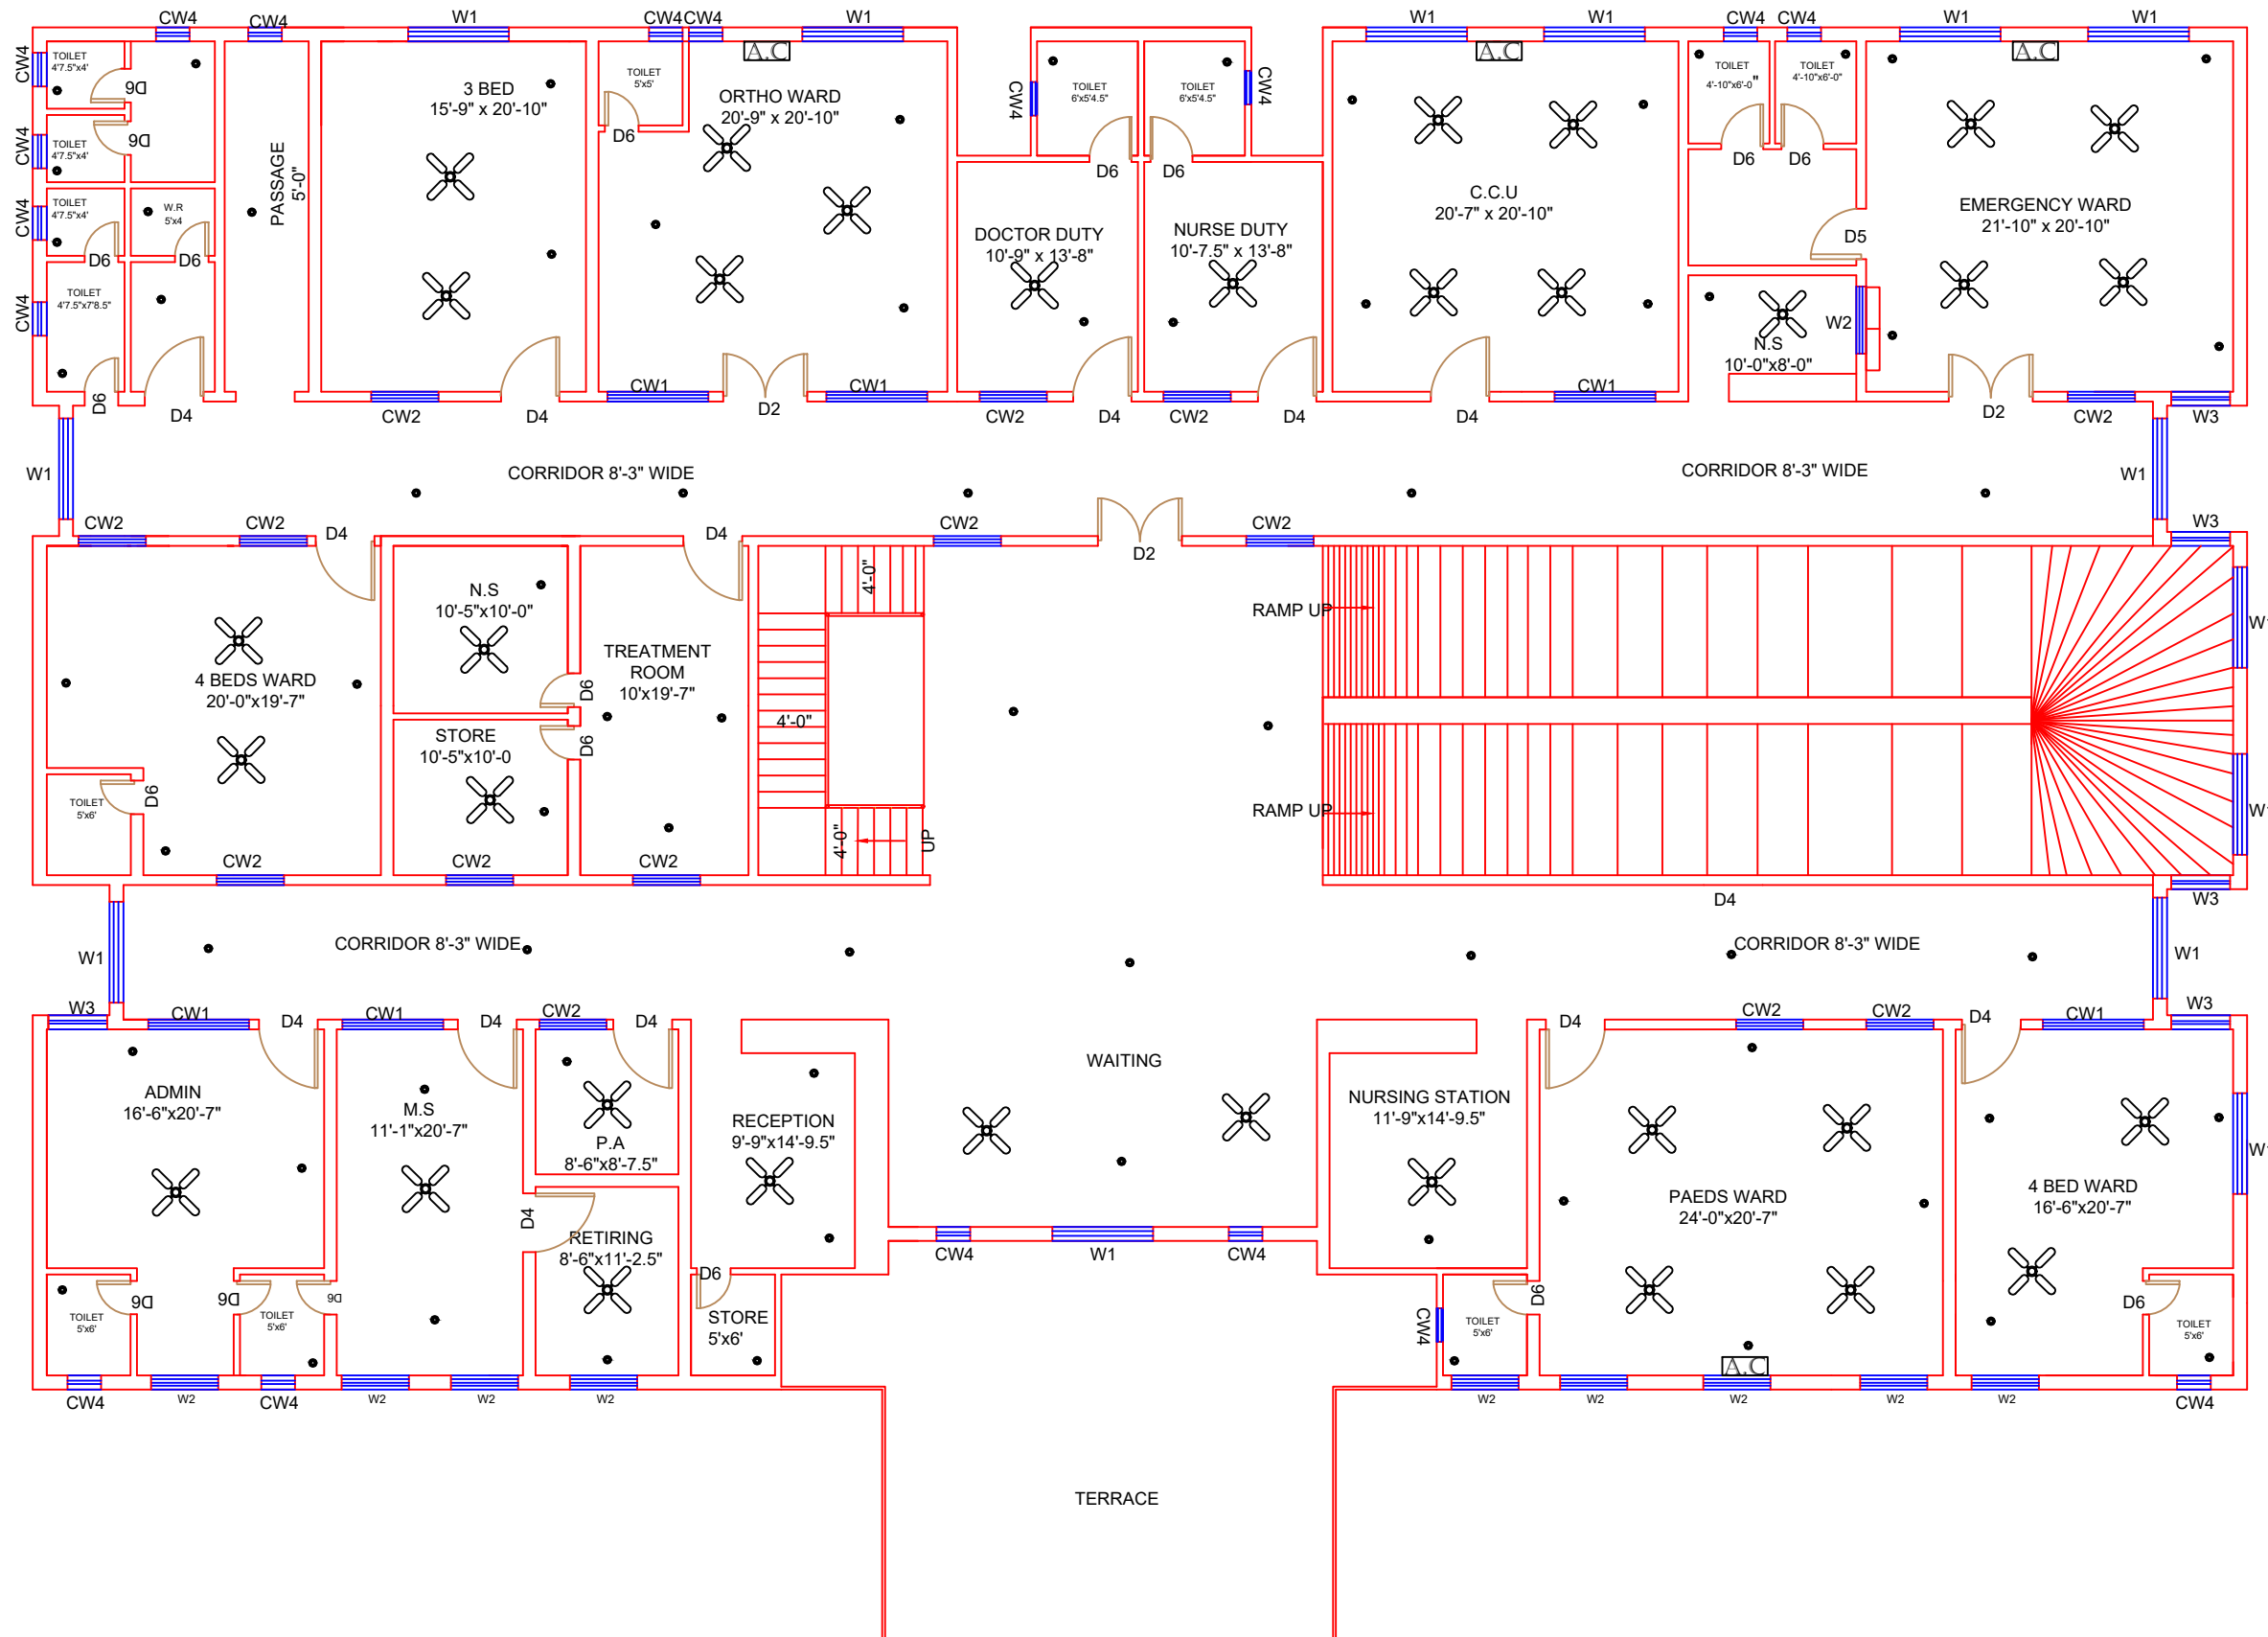

Legends:

Residential Area	
Road	
Wall	
Power Line	
OHT	
Tree	
Man Hole	
Tube Well	
Light Pole	
Lawns	
Earthen Areas	
Asphalts Roads	
Tough Pavers	
P.C.C / Plinth Protection	
Boundary Wall	
Brick Pavers / Soling	
Drain	
Tap	
Hand Pump	
Air Conditioner	
Tube Light	
Fan	
Roof Light	
Bulb	

AREA	
AREA WITHIN BOUNDARY WALL	190422.658 Sft
AREA OF CLINICAL BLOCK	30693.85 Sft
PLINTH AREA OF BLOCK	19836.813 Sft

OPENING SCHEDULE OF DOORS AND WINDOWS					
DOORS	WIDTH	HEIGHT	WINDOWS	WIDTH	HEIGHT
D2	5'-0"	7'-0"	W1	6'-0"	6'-0"
D4	3'-6"	7'-0"	W2	4'-0"	4'-0"
D5	3'-0"	7'-0"	W3	3'-6"	3'-6"
D6	2'-6"	7'-0"	W4	2'-0"	2'-0"

Project:
**CAD MAPPING OF TEHSIL
HEAD QUARTER HOSPITALS,
PUNJAB**

Client: GOVERNMENT OF THE PUNJAB
PRIMARY & SECONDARY
HEALTHCARE DEPARTMENT

Consultant: SKAFS CONSULTANT (Pvt.)
Limited
ENGINEERING AND ENVIRONMENT
CONSULTANT

Drawing Title: **THQ LALLIAN
ELECTRICAL PLAN (FIRST FLOOR)**

Drawing No. **SKAFS/LALLIAN /16**