

MASTER PLAN OF THQ HOSPITAL PIPLAN

PART 1

PART 2

PART 3

PART 4



Legends:

RESIDENTIAL AREA	
ROAD	
WALL	
POWER LINE	
OHT	
TREE	
MANHOLE	
TUBE WELL	
LIGHT POLE	
LAWNS	
EARTHEN AREAS	
ASPHALTS ROADS	
TOUGH PAVERS	
P.C.C /PLINTH PROTECTION	
BOUNDARY WALL	
TAP	
HAND PUMP	
BRICK PAVERS	
AIR CONDITIONER	
TUBE LIGHT	
FAN	
ROOF LIGHT	
BULB	

AREA	
AREA WITHIN BOUNDARY WALL	333119.11 SFT
AREA OF CLINICAL BLOCK	21383.63
PLINTH AREA OF BLOCK	SFT

OPENING SCHEDULE OF DOORS AND WINDOWS					
DOORS	WIDTH	HEIGHT	WINDOWS	WIDTH	HEIGHT
D1	2'-6"	7'-0"	W1	2'-6"	2'-6"
D2	3'-0"	7'-0"	W2	3'-0"	3'-0"
D3	3'-6"	7'-0"	W3	4'-0"	4'-0"
D4	4'-0"	7'-0"	W4	5'-0"	5'-0"
D5	5'-0"	7'-0"	W5	6'-0"	6'-0"
D6	6'-0"	7'-0"	W6	8'-0"	8'-0"
D7	7'-0"	7'-0"	W7	9'-0"	9'-0"
D8	8'-0"	7'-0"	V1		
D9			V2		

Client:

GOVERNMENT OF THE PUNJAB
PRIMARY & SECONDARY
HEALTHCARE DEPARTMENT

Project:

CAD MAPPING OF TEHSIL
HEAD QUARTER HOSPITALS,
PUNJAB

Consultant:

SKAFS CONSULTANT (Pvt.) Limited
ENGINEERING AND ENVIRONMENT CONSULTANT


Drawing Title:

THQ PIPLAN
HOSPITAL MASTER PLAN

Authorized By: SKAFS	Reviewed By Co-Team Leader	Scale: 1:400
Prepared By: CAD TEAMS	Date: FEB, 2017	
Drawing No.		SKAFS/PIPLAN /03

MASTER PLAN OF THQ HOSPITAL PIPLAN

PART 1

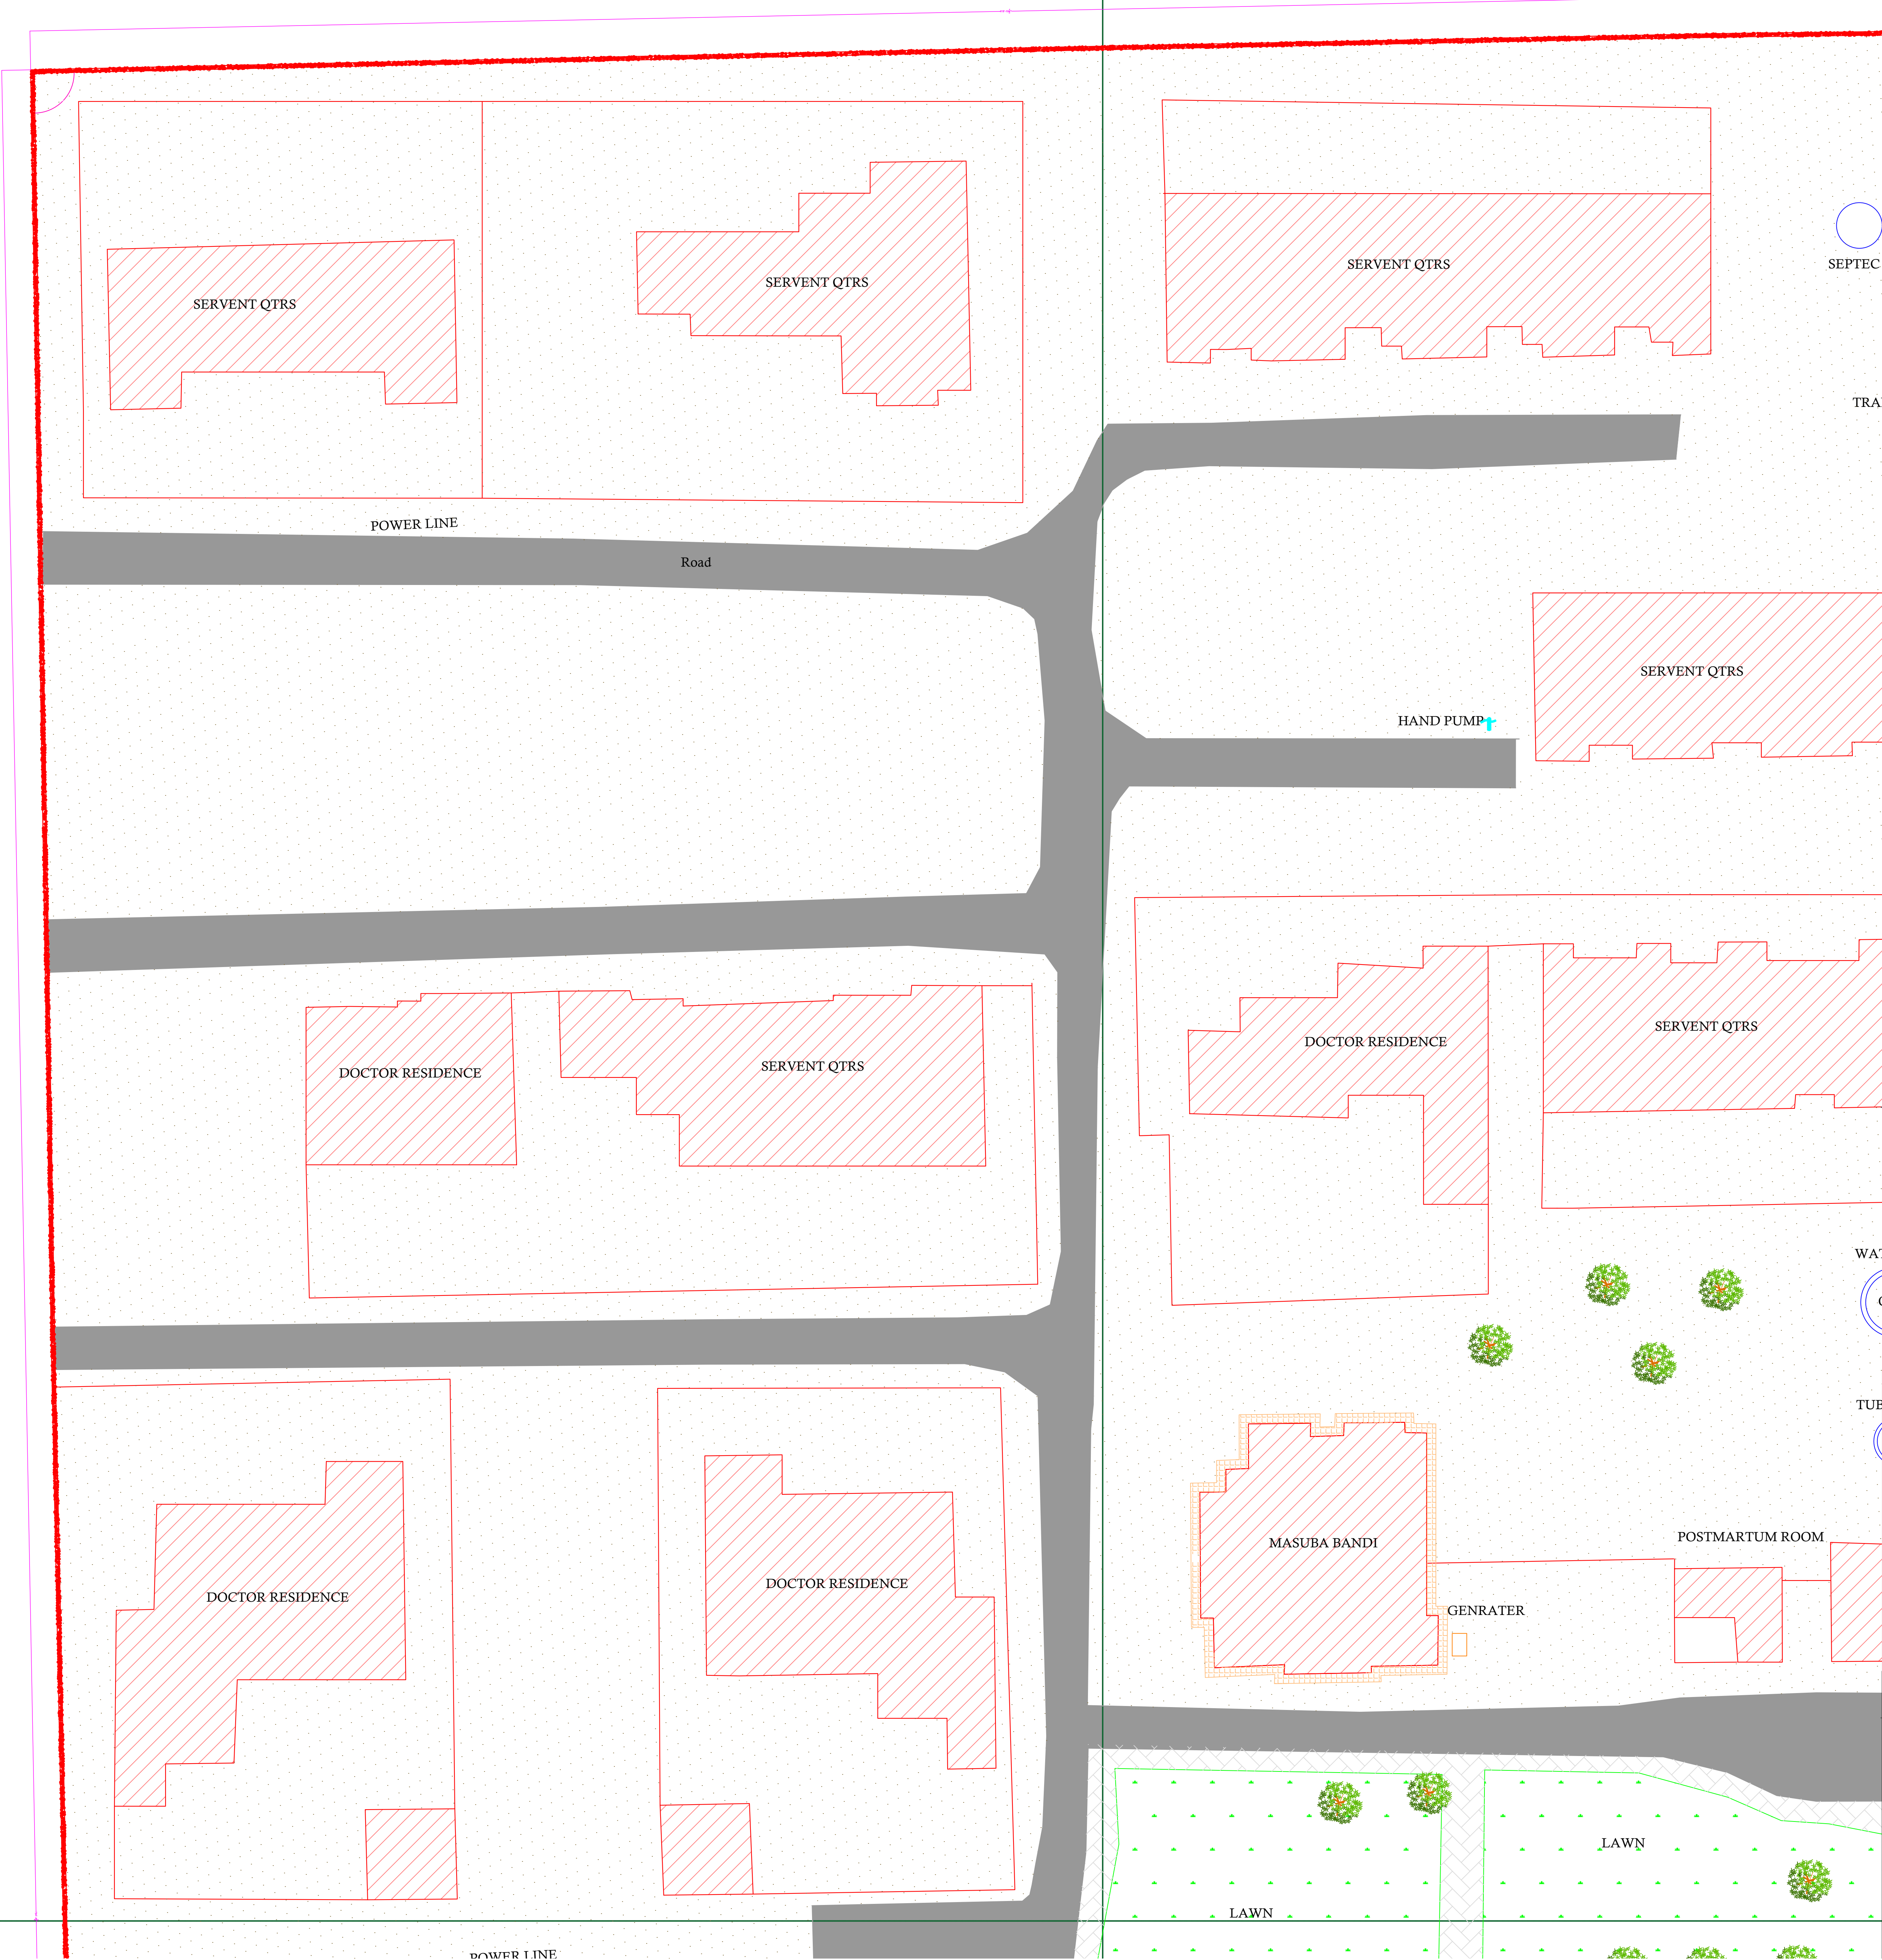

Legends:

RESIDENTIAL AREA	
ROAD	
WALL	
POWER LINE	
OHT	
TREE	
MANHOLE	
TUBE WELL	
LIGHT POLE	
LAWNS	
EARTHEN AREAS	
ASPHALTS ROADS	
TOUGH PAVERS	
P.C.C /PLINTH PROTECTION	
BOUNDARY WALL	
TAP	
HAND PUMP	
BRICK PAVERS	
AIR CONDITIONER	
TUBE LIGHT	
FAN	
ROOF LIGHT	
BULB	

AREA	
AREA WITHIN BOUNDARY WALL	333119.11 SFT
AREA OF CLINICAL BLOCK	21383.63 SFT
PLINTH AREA OF BLOCK	SFT

OPENING SCHEDULE OF DOORS AND WINDOWS					
DOORS	WIDTH	HEIGHT	WINDOWS	WIDTH	HEIGHT
D1	2'-6"	7'-0"	W1	2'-6"	2'-6"
D2	3'-0"	7'-0"	W2	3'-0"	3'-0"
D3	3'-6"	7'-0"	W3	4'-0"	4'-0"
D4	4'-0"	7'-0"	W4	5'-0"	5'-0"
D5	5'-0"	7'-0"	W5	6'-0"	6'-0"
D6	6'-0"	7'-0"	W6	8'-0"	8'-0"
D7	7'-0"	7'-0"	W7	9'-0"	9'-0"
D8	8'-0"	7'-0"	V1		
D9			V2		

Client:



**GOVERNMENT OF THE PUNJAB
PRIMARY & SECONDARY
HEALTHCARE DEPARTMENT**

Project:

**CAD MAPPING OF TEHSIL
HEAD QUARTER HOSPITALS,
PUNJAB**

Consultant:





SKAFS CONSULTANT (Pvt.) Limited
ENGINEERING AND ENVIRONMENT CONSULTANT

Drawing Title:




**THQ PIPLAN
HOSPITAL MASTER PLAN
PART 1**

Authorized By: SKAFS	Reviewed By: Co-Team Leader	Scale:
Prepared By: CAD TEAMS	Date: FEB, 2017	Sheet:
Drawing No.		SKAFS/PIPLAN /04

MASTER PLAN OF THQ HOSPITAL PIPLAN
PART 2

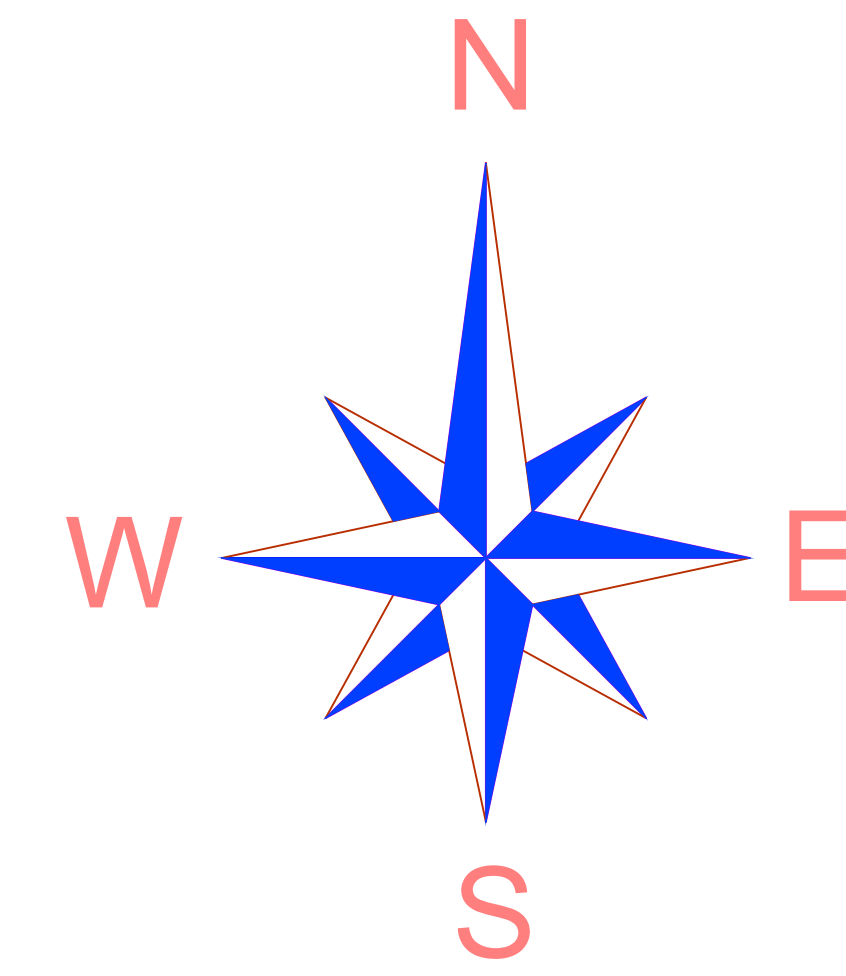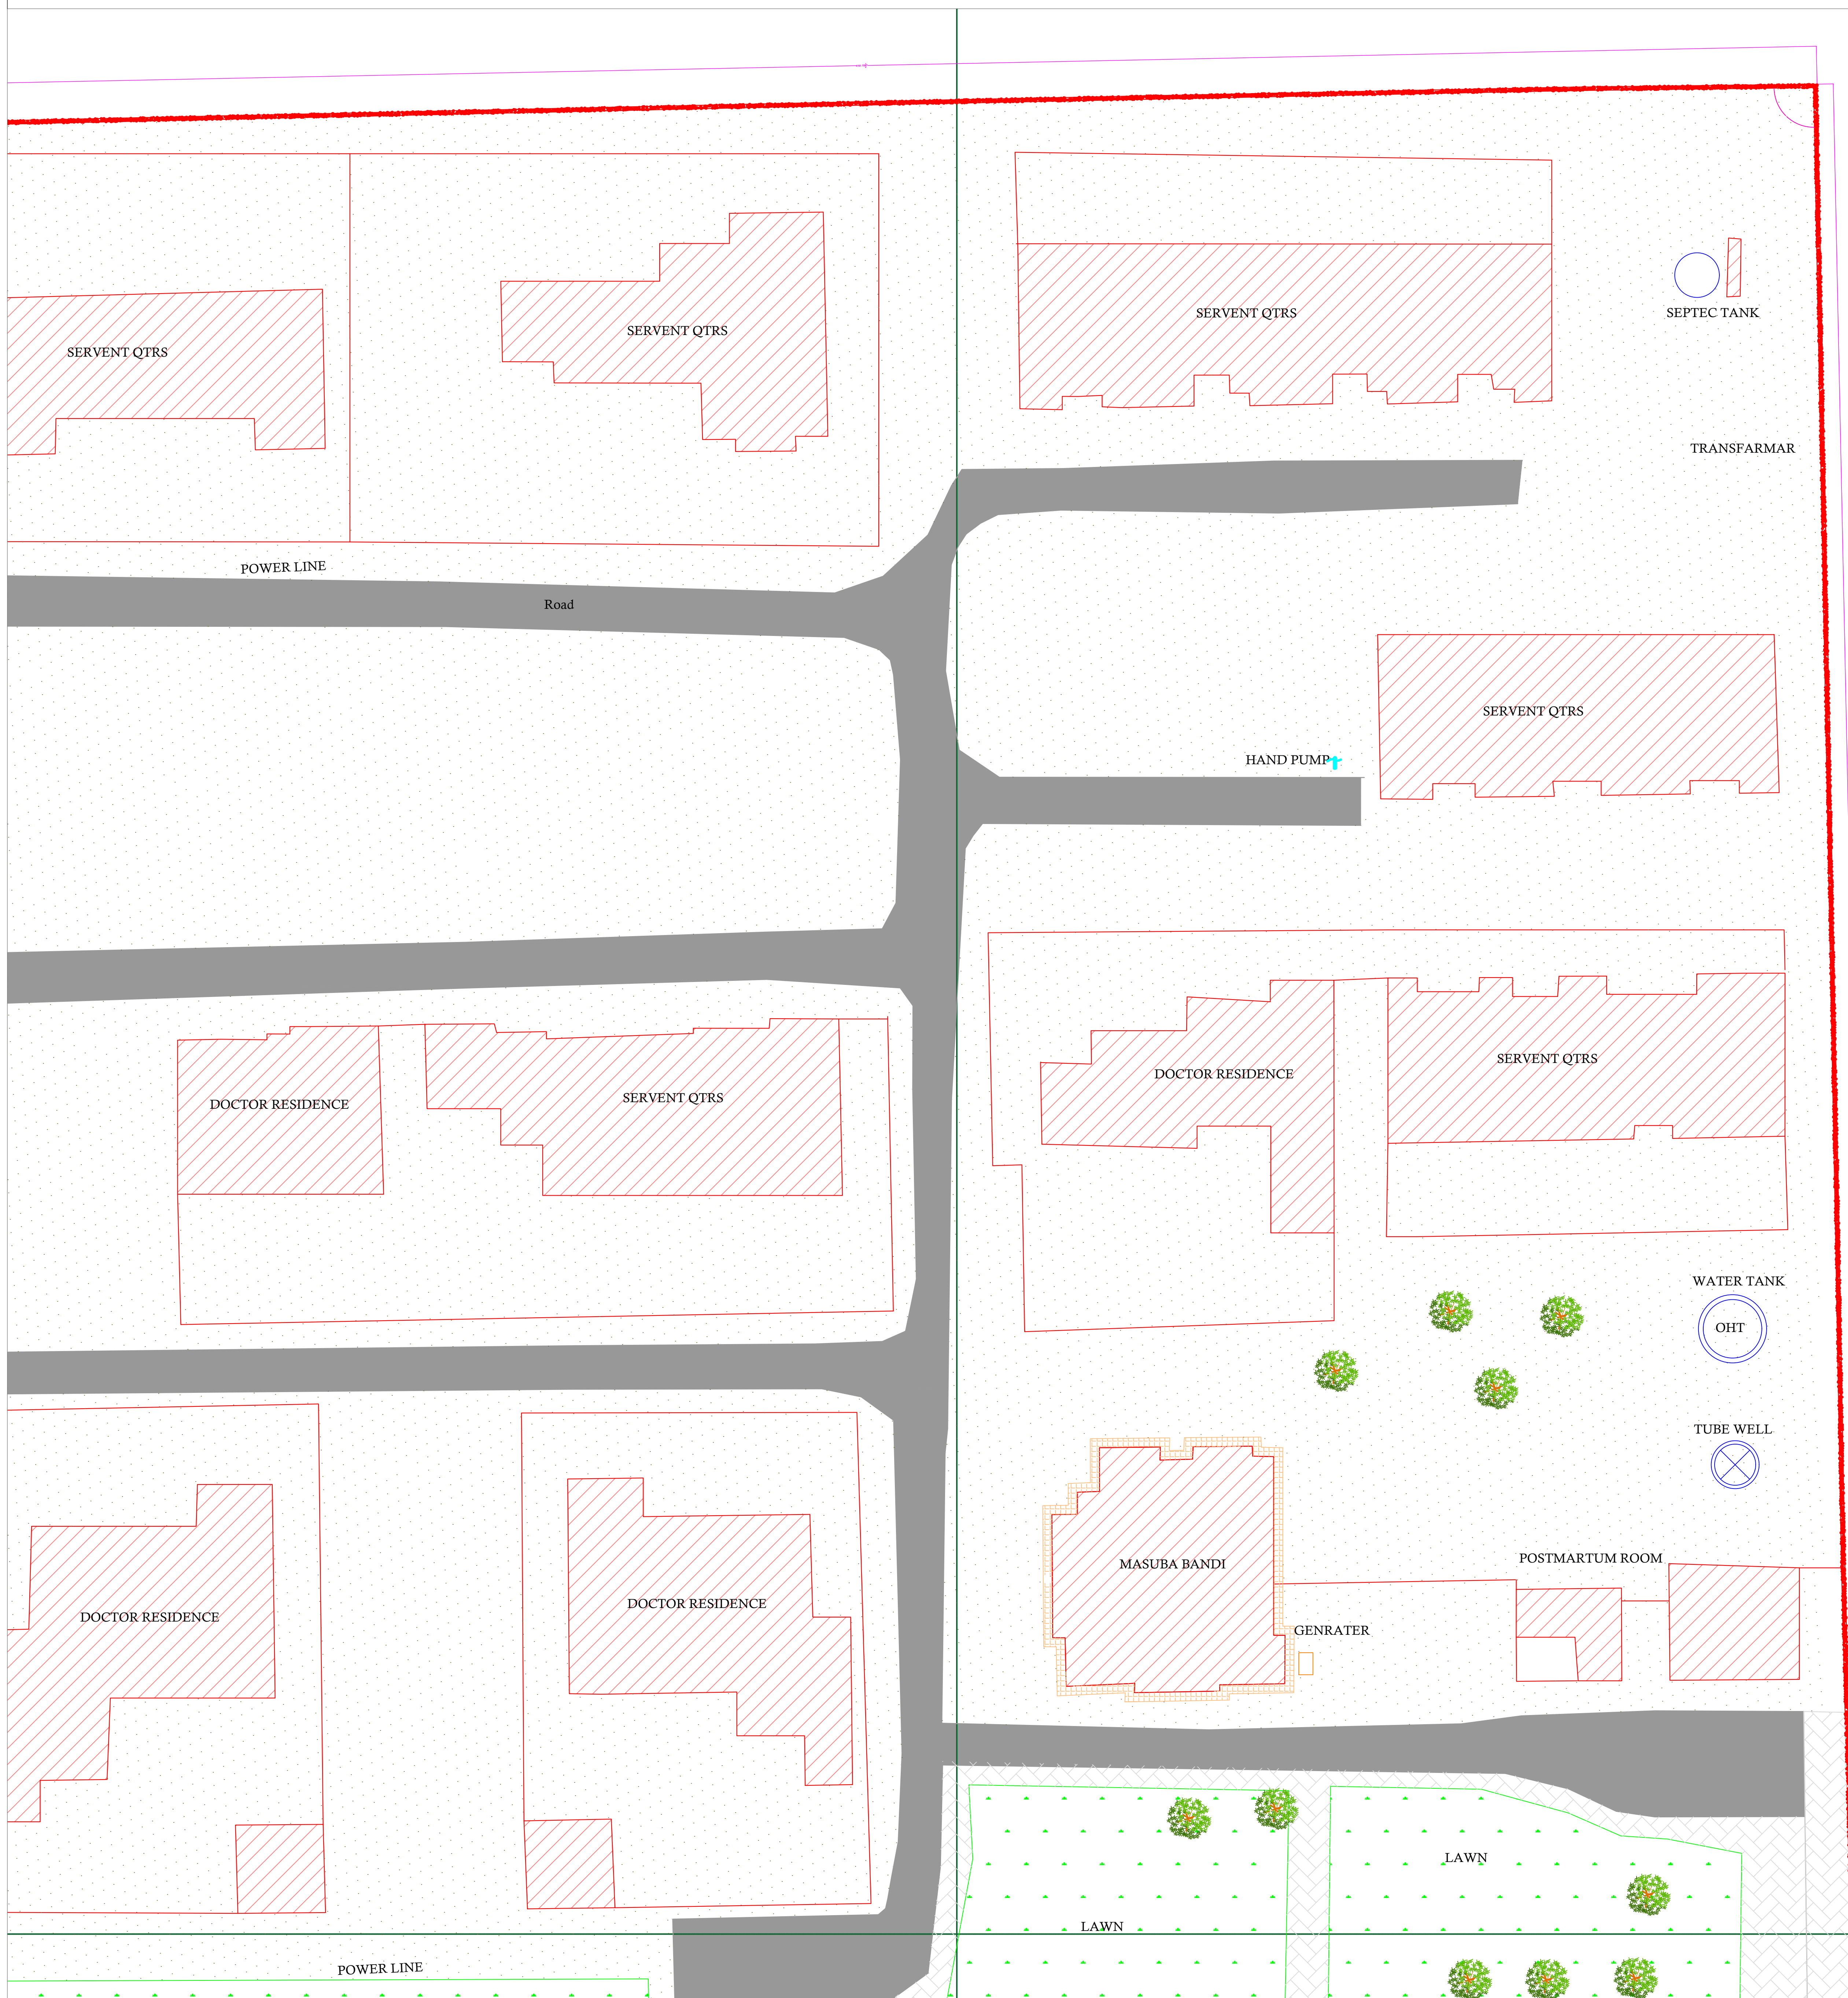

Legends:

   RESIDENTIAL AREA	
ROAD	
WALL	
POWER LINE	
OHT	
TREE	
MANHOLE	
TUBE WELL	
LIGHT POLE	
LAWNS	
EARTHEN AREAS	
ASPHALTS ROADS	
TOUGH PAVERS	
P.C.C /PLINTH PROTECTION	
BOUNDARY WALL	
TAP	
HAND PUMP	
BRICK PAVERS	
AIR CONDITIONER	
TUBE LIGHT	
FAN	
ROOF LIGHT	
BULB	

AREA	
AREA WITHIN BOUNDARY WALL	333119.11 SFT
AREA OF CLINICAL BLOCK	21383.63
PLINTH AREA OF BLOCK	SFT

OPENING SCHEDULE OF DOORS AND WINDOWS					
DOORS	WIDTH	HEIGHT	WINDOWS	WIDTH	HEIGHT
D1	2'-6"	7'-0"	W1	2'-6"	2'-6"
D2	3'-0"	7'-0"	W2	3'-0"	3'-0"
D3	3'-6"	7'-0"	W3	4'-0"	4'-0"
D4	4'-0"	7'-0"	W4	5'-0"	5'-0"
D5	5'-0"	7'-0"	W5	6'-0"	6'-0"
D6	6'-0"	7'-0"	W6	8'-0"	8'-0"
D7	7'-0"	7'-0"	W7	9'-0"	9'-0"
D8	8'-0"	7'-0"	V1		
D9			V2		

Client:



GOVERNMENT OF THE PUNJAB
PRIMARY & SECONDARY
HEALTHCARE DEPARTMENT

Project:

CAD MAPPING OF TEHSIL HEAD QUARTER HOSPITALS, PUNJAB

Consultant:



SKAFS CONSULTANT (Pvt.) Limited
ENGINEERING AND ENVIRONMENT CONSULTANT

Drawing Title: **THQ PIPLAN
HOSPITAL MASTER PLAN
PART 2**

Authorized By: SKAFS	Reviewed By Co-Team Leader	Scale:
Prepared By: CAD TEAMS	Date: FEB, 2017	Sheet:

Drawing No.	SKAFS/PIPLAN	/05
-------------	---------------------	------------

MASTER PLAN OF THQ HOSPITAL PIPLAN
PART 3



Legends:	
RESIDENTIAL AREA	
ROAD	
WALL	
POWER LINE	
OHT	
TREE	
MANHOLE	
TUBE WELL	
LIGHT POLE	
LAWNS	
EARTHEN AREAS	
ASPHALTS ROADS	
TOUGH PAVERS	
P.C.C /PLINTH PROTECTION	
BOUNDARY WALL	
TAP	
HAND PUMP	
BRICK PAVERS	
AIR CONDITIONER	
TUBE LIGHT	
FAN	
ROOF LIGHT	
BULB	

AREA	
AREA WITHIN BOUNDARY WALL	333119.11 SFT
AREA OF CLINICAL BLOCK	21383.63
PLINTH AREA OF BLOCK	SFT

OPENING SCHEDULE OF DOORS AND WINDOWS					
DOORS	WIDTH	HEIGHT	WINDOWS	WIDTH	HEIGHT
D1	2'-6"	7'-0"	W1	2'-6"	2'-6"
D2	3'-0"	7'-0"	W2	3'-0"	3'-0"
D3	3'-6"	7'-0"	W3	4'-0"	4'-0"
D4	4'-0"	7'-0"	W4	5'-0"	5'-0"
D5	5'-0"	7'-0"	W5	6'-0"	6'-0"
D6	6'-0"	7'-0"	W6	8'-0"	8'-0"
D7	7'-0"	7'-0"	W7	9'-0"	9'-0"
D8	8'-0"	7'-0"	V1		
D9			V2		

Client:



**GOVERNMENT OF THE PUNJAB
PRIMARY & SECONDARY
HEALTHCARE DEPARTMENT**

Project:

CAD MAPPING OF TEHSIL HEAD QUARTER HOSPITALS, PUNJAB

Consultant:



SKAFS CONSULTANT (Pvt.) Limited
ENGINEERING AND ENVIRONMENT CONSULTANT

Drawing Title: **THQ PIPLAN
HOSPITAL MASTER PLAN
PART 3**

Authorized By: SKAFS	Reviewed By Co-Team Leader	Scale:
Prepared By: CAD TEAMS	Date: FEB, 2017	
Drawing No. SKAFS/BIPLAN /06		

MASTER PLAN OF THQ HOSPITAL PIPLAN

PART 4



Legends:

RESIDENTIAL AREA	
ROAD	
WALL	
POWER LINE	
OHT	
TREE	
MANHOLE	
TUBE WELL	
LIGHT POLE	
LAWNS	
EARTHEN AREAS	
ASPHALTS ROADS	
TOUGH PAVERS	
P.C.C /PLINTH PROTECTION	
BOUNDARY WALL	
TAP	
HAND PUMP	
BRICK PAVERS	
AIR CONDITIONER	
TUBE LIGHT	
FAN	
ROOF LIGHT	
BULB	

AREA	
AREA WITHIN BOUNDARY WALL	333119.11 SFT
AREA OF CLINICAL BLOCK	21383.63
PLINTH AREA OF BLOCK	SFT

OPENING SCHEDULE OF DOORS AND WINDOWS					
DOORS	WIDTH	HEIGHT	WINDOWS	WIDTH	HEIGHT
D1	2'-6"	7'-0"	W1	2'-6"	2'-6"
D2	3'-0"	7'-0"	W2	3'-0"	3'-0"
D3	3'-6"	7'-0"	W3	4'-0"	4'-0"
D4	4'-0"	7'-0"	W4	5'-0"	5'-0"
D5	5'-0"	7'-0"	W5	6'-0"	6'-0"
D6	6'-0"	7'-0"	W6	8'-0"	8'-0"
D7	7'-0"	7'-0"	W7	9'-0"	9'-0"
D8	8'-0"	7'-0"	V1		
D9			V2		

Client:



GOVERNMENT OF THE PUNJAB
PRIMARY & SECONDARY
HEALTHCARE DEPARTMENT

Project:

CAD MAPPING OF TEHSIL
HEAD QUARTER HOSPITALS,
PUNJAB

Consultant:



SKAFS CONSULTANT (Pvt.) Limited
ENGINEERING AND ENVIRONMENT CONSULTANT

Drawing Title:


THQ PIPLAN
HOSPITAL MASTER PLAN
PART 4

Authorized By: SKAFS	Reviewed By Co-Team Leader	Scale:
Prepared By: CAD TEAMS	Date: FEB, 2017	
Drawing No.		SKAFS/PIPLAN /07

CLINICAL BLOCK OF THQ HOSPITAL PIPLAN


GROUND FLOOR

PART 1

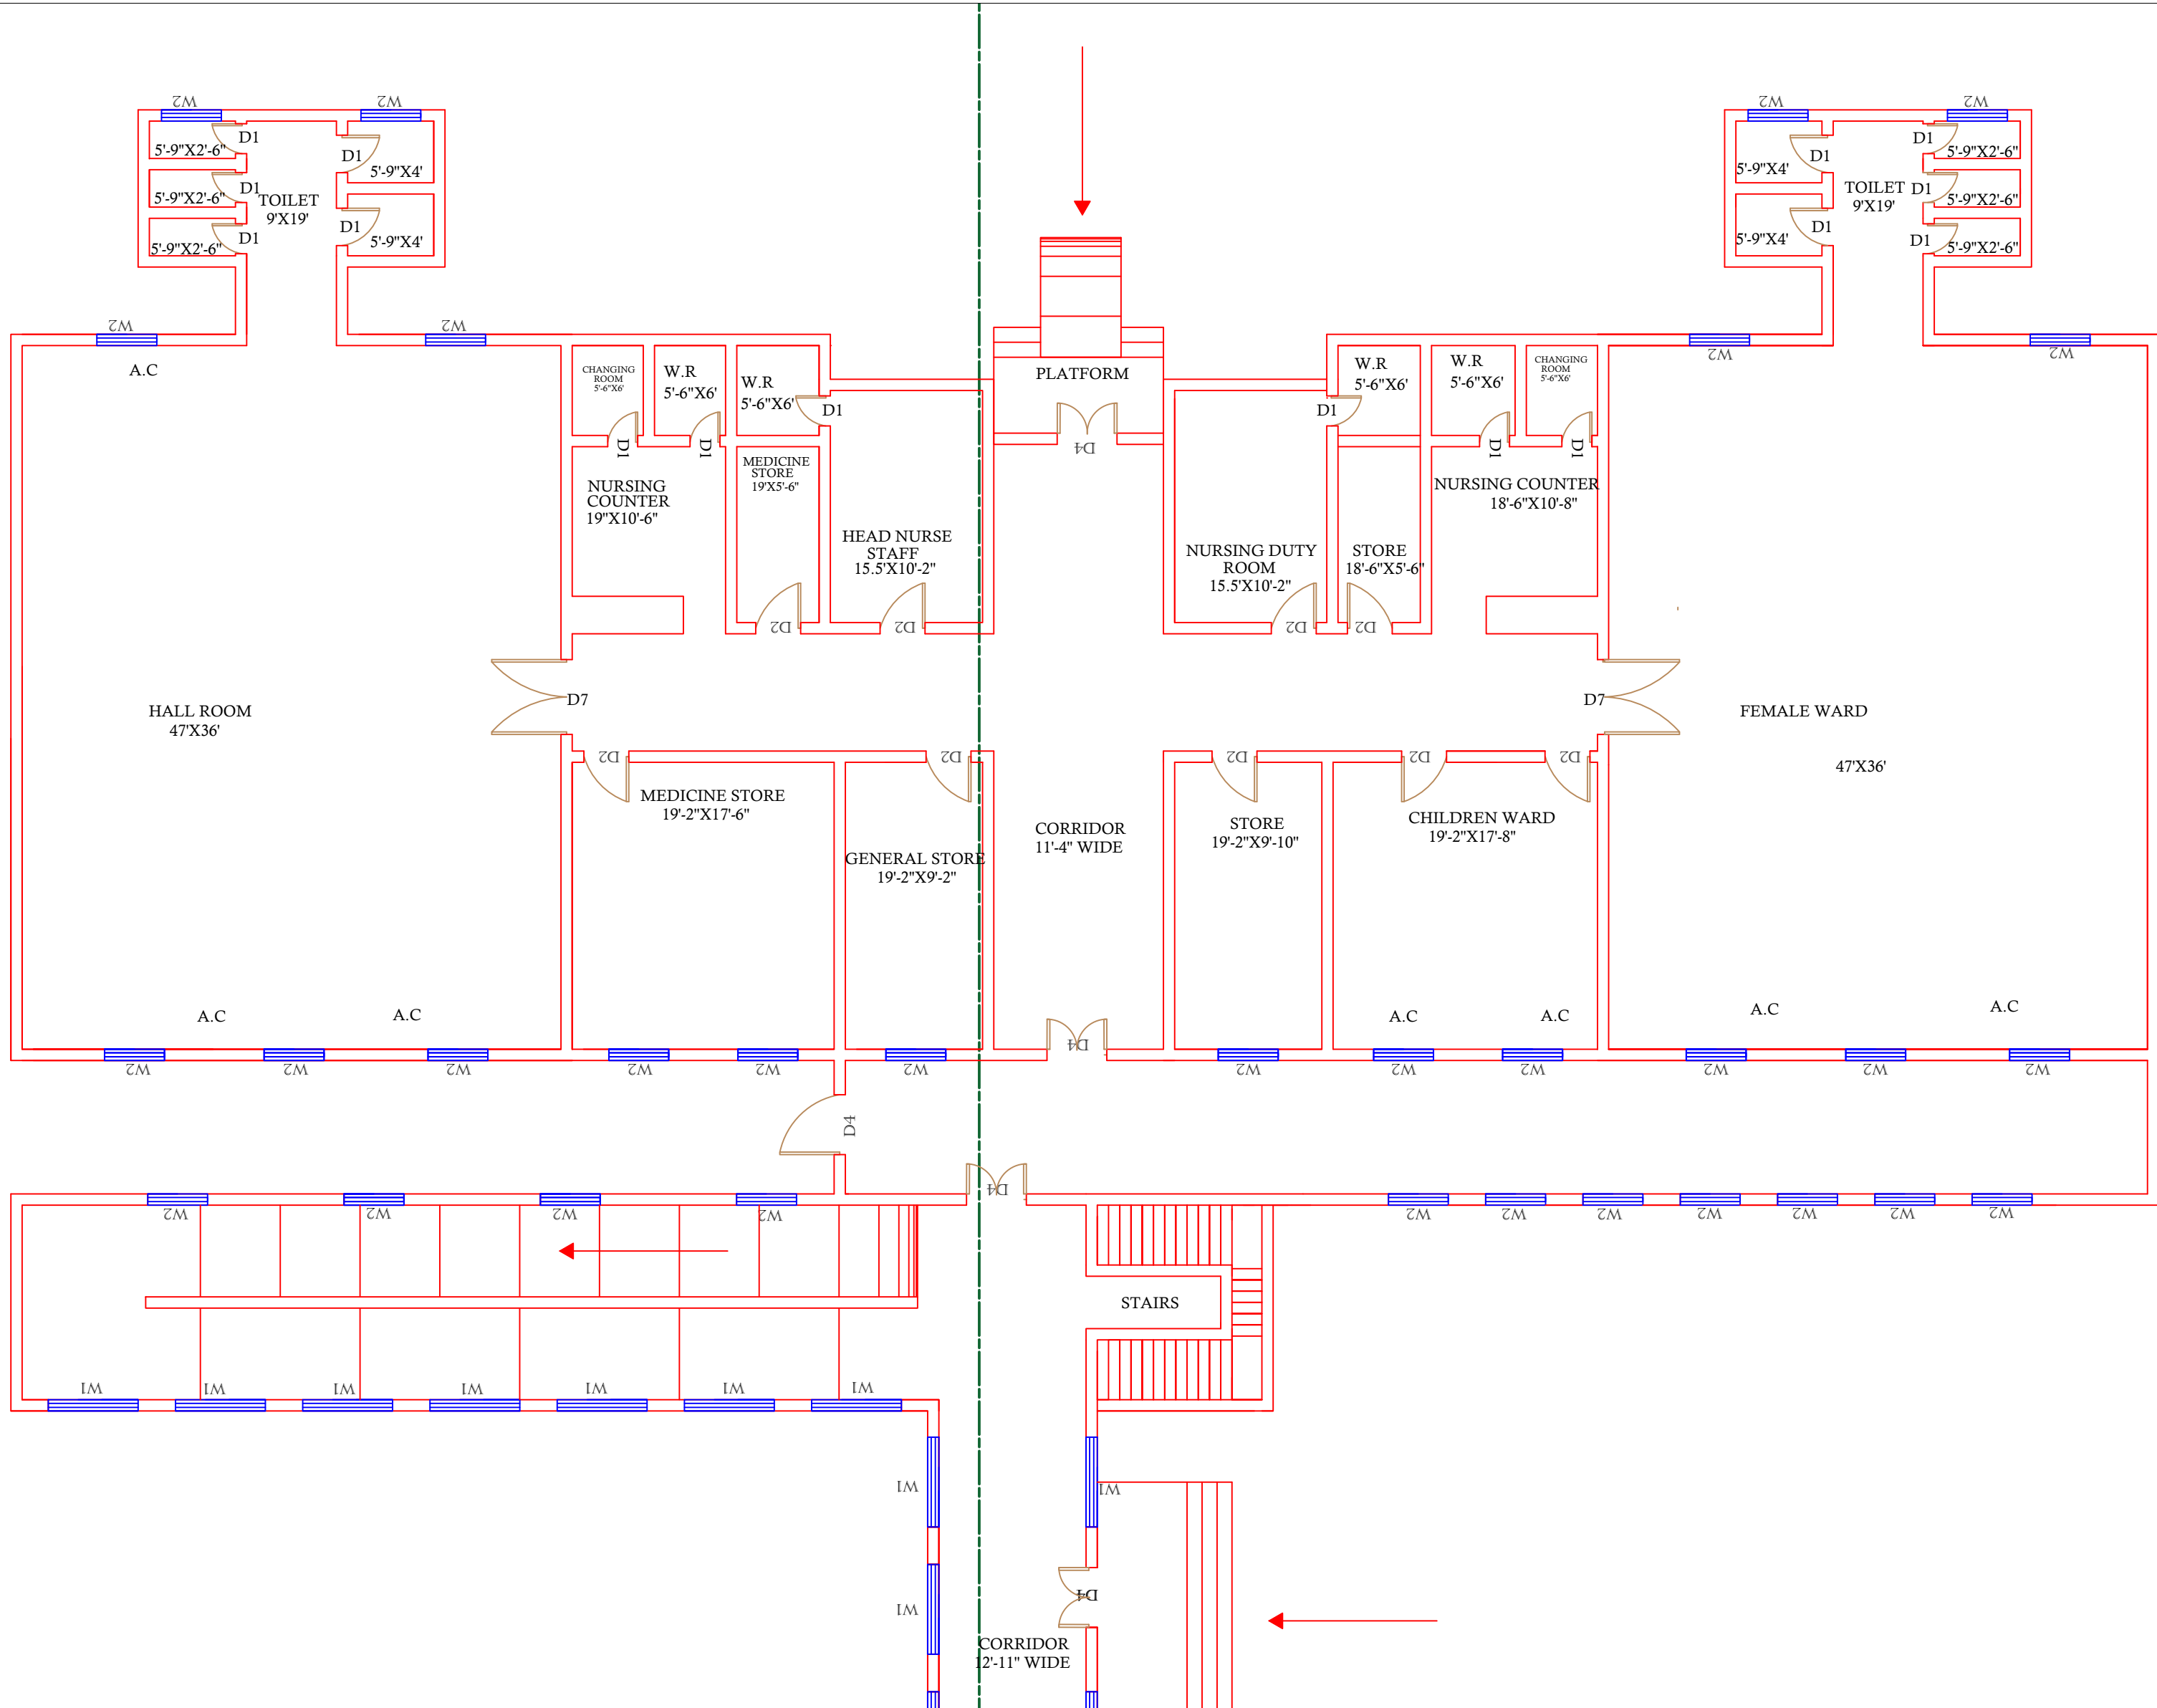

PART 2

PART 3

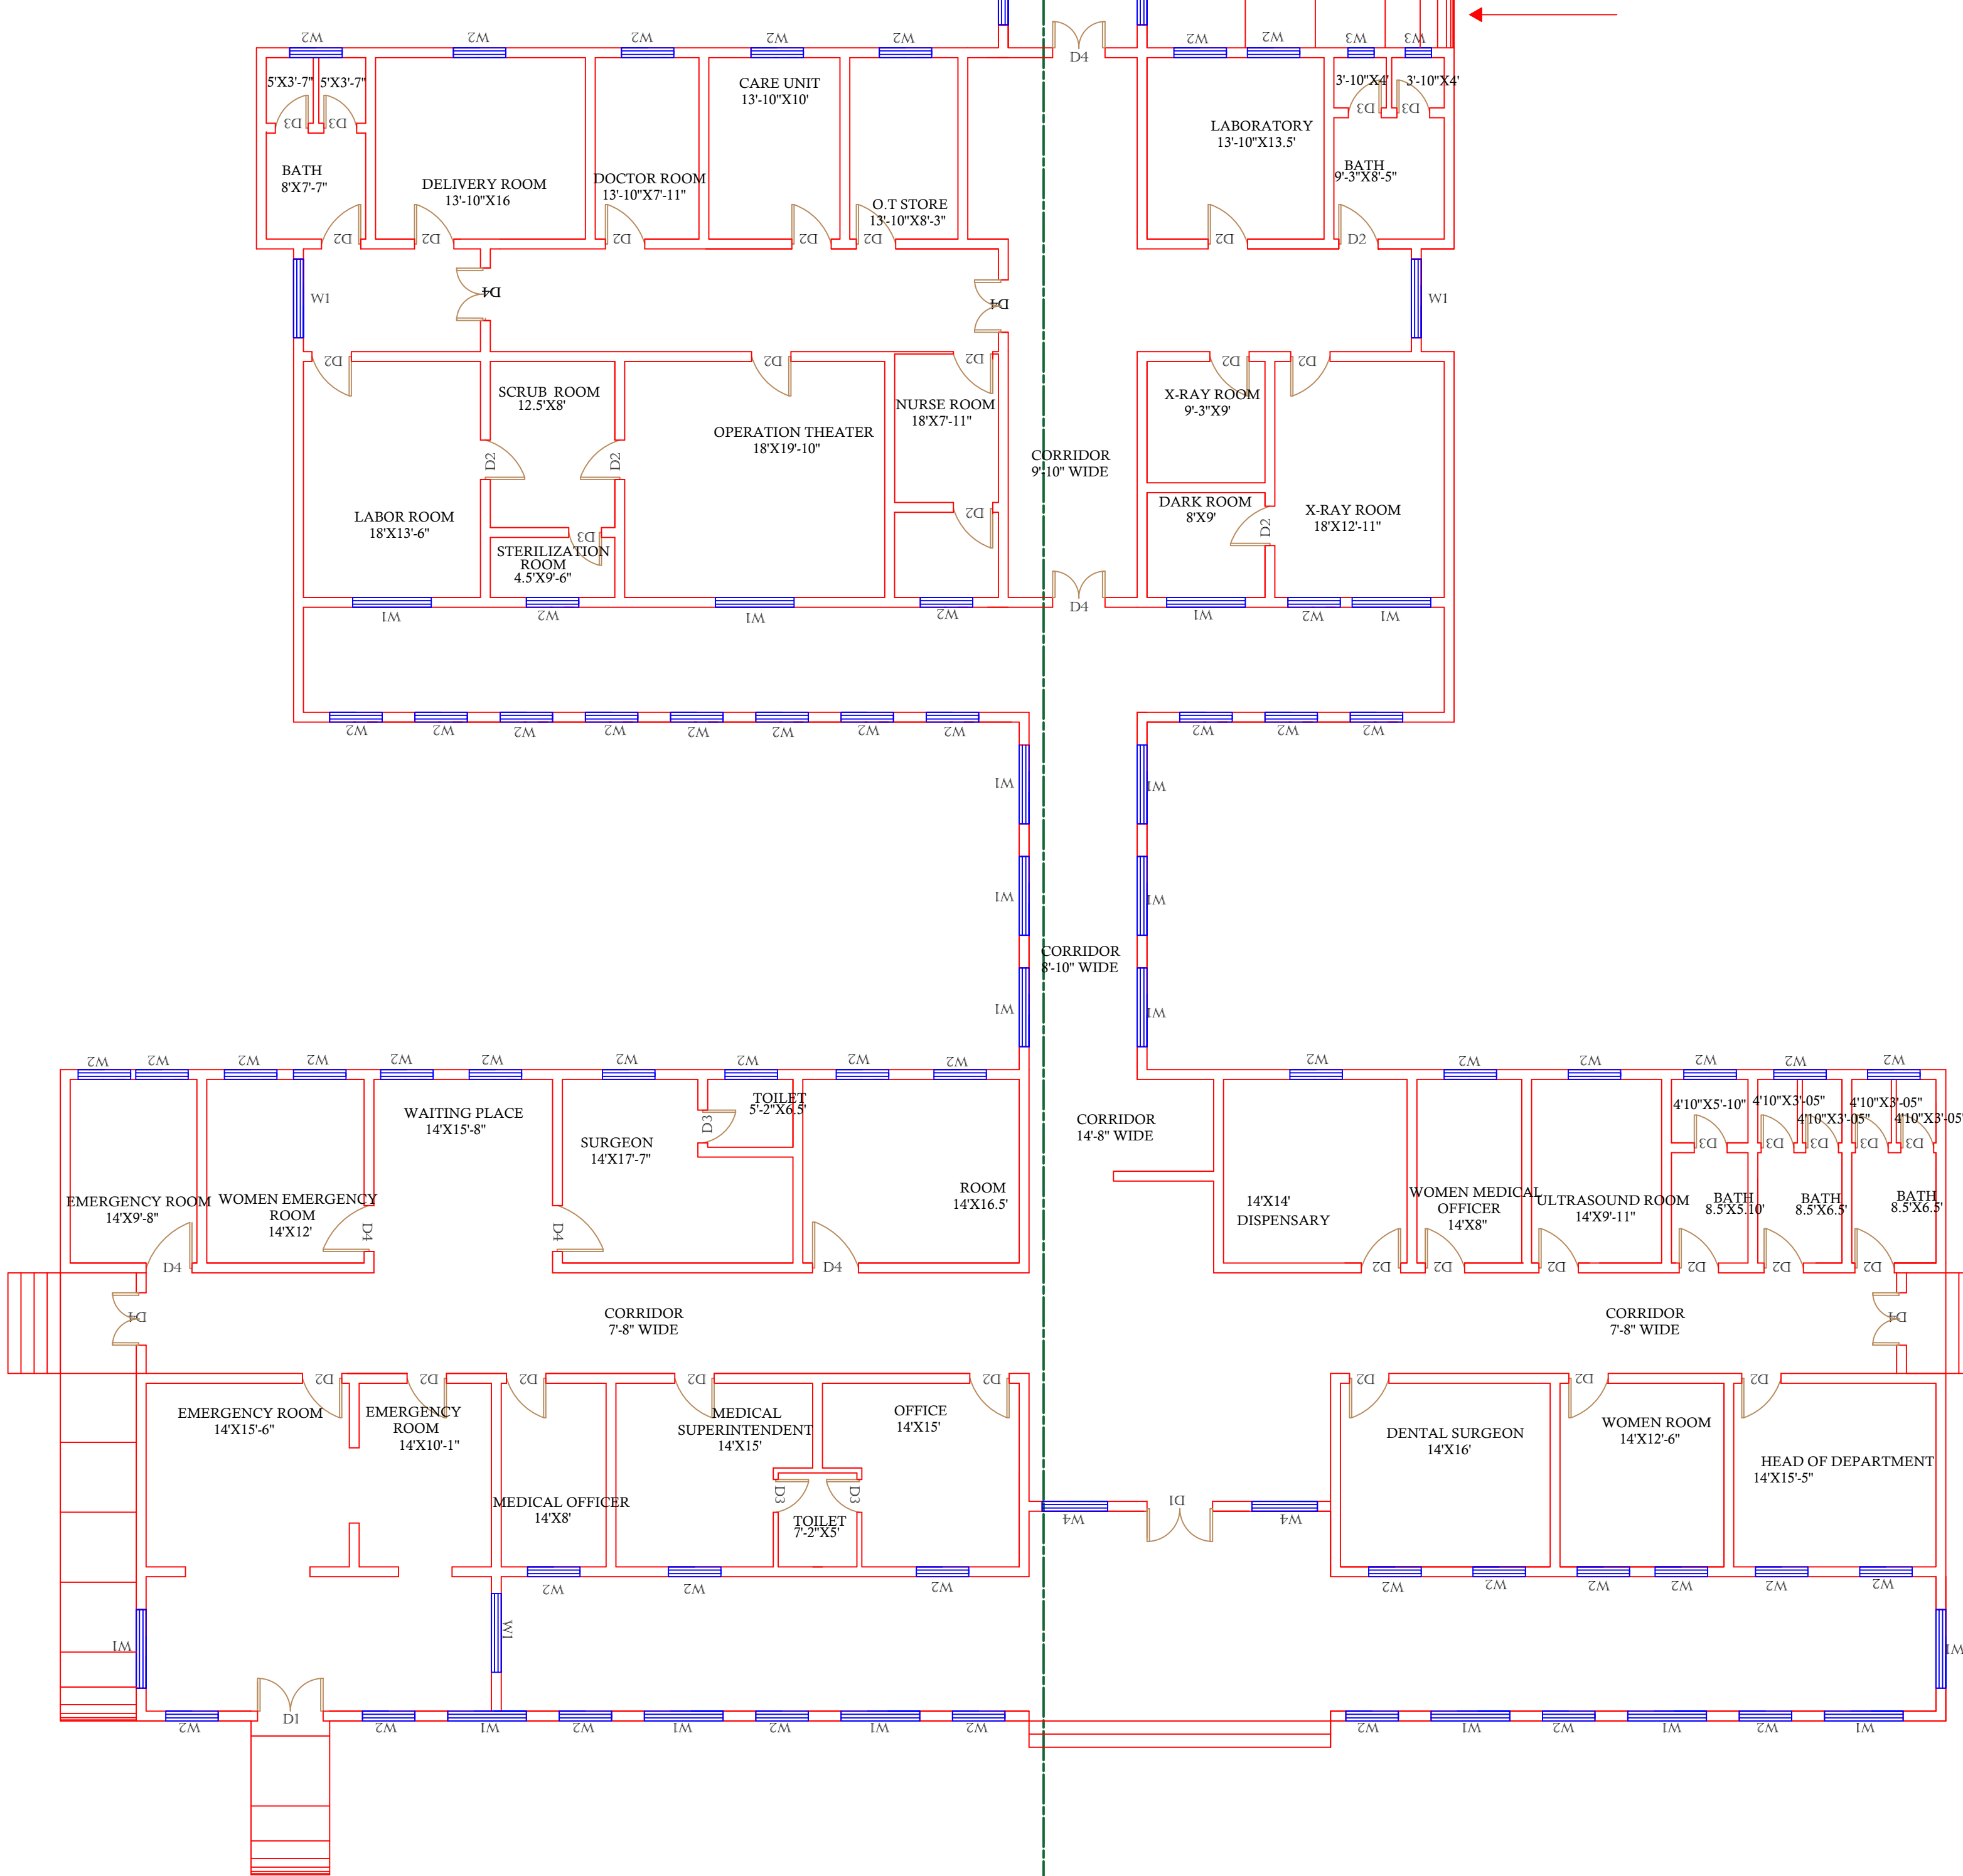

PART 4

Legends:

RESIDENTIAL AREA

ROAD

WALL

POWER LINE

OHT

TREE

MANHOLE

TUBE WELL

LIGHT POLE

LAWNS

EARTHEN AREAS

ASPHALTS ROADS

TOUGH PAVERS

P.C.C /PLINTH PROTECTION

BOUNDARY WALL

TAP

HAND PUMP

BRICK PAVERS

AIR CONDITIONER

TUBE LIGHT

FAN

ROOF LIGHT

BULB

AREA

AREA WITHIN BOUNDARY WALL

AREA OF CLINICAL BLOCK

PLINTH AREA OF BLOCK

333119.11 SFT

21383.63

SFT

OPENING SCHEDULE OF DOORS AND WINDOWS

DOORS	WIDTH	HEIGHT	WINDOWS	WIDTH	HEIGHT
D1	2'-6"	7'-0"	W1	2'-6"	2'-6"
D2	3'-0"	7'-0"	W2	3'-0"	3'-0"
D3	3'-6"	7'-0"	W3	4'-0"	4'-0"
D4	4'-0"	7'-0"	W4	5'-0"	5'-0"
D5	5'-0"	7'-0"	W5	6'-0"	6'-0"
D6	6'-0"	7'-0"	W6	8'-0"	8'-0"
D7	7'-0"	7'-0"	W7	9'-0"	9'-0"
D8	8'-0"	7'-0"	V1		
D9			V2		

Client:



GOVERNMENT OF THE PUNJAB
PRIMARY & SECONDARY
HEALTHCARE DEPARTMENT

Project:

CAD MAPPING OF TEHSIL
HEAD QUARTER HOSPITALS,
PUNJAB

Consultant:



SKAFS CONSULTANT (Pvt.) Limited
ENGINEERING AND ENVIRONMENT CONSULTANT

Drawing Title:

THQ PIPLAN
HOSPITAL MAIN BUILDING
CLINICAL BLOCK PLAN

Authorized By:

SKAFS

Reviewed By:

Co-Team Leader

Scale:

1:400

Prepared By:

CAD TEAMS

Date:


FEB, 2017

Drawing No.

SKAFS/PIPLAN /08

CLINICAL BLOCK OF THQ HOSPITAL PIPLAN

GROUND FLOOR (PART 1)

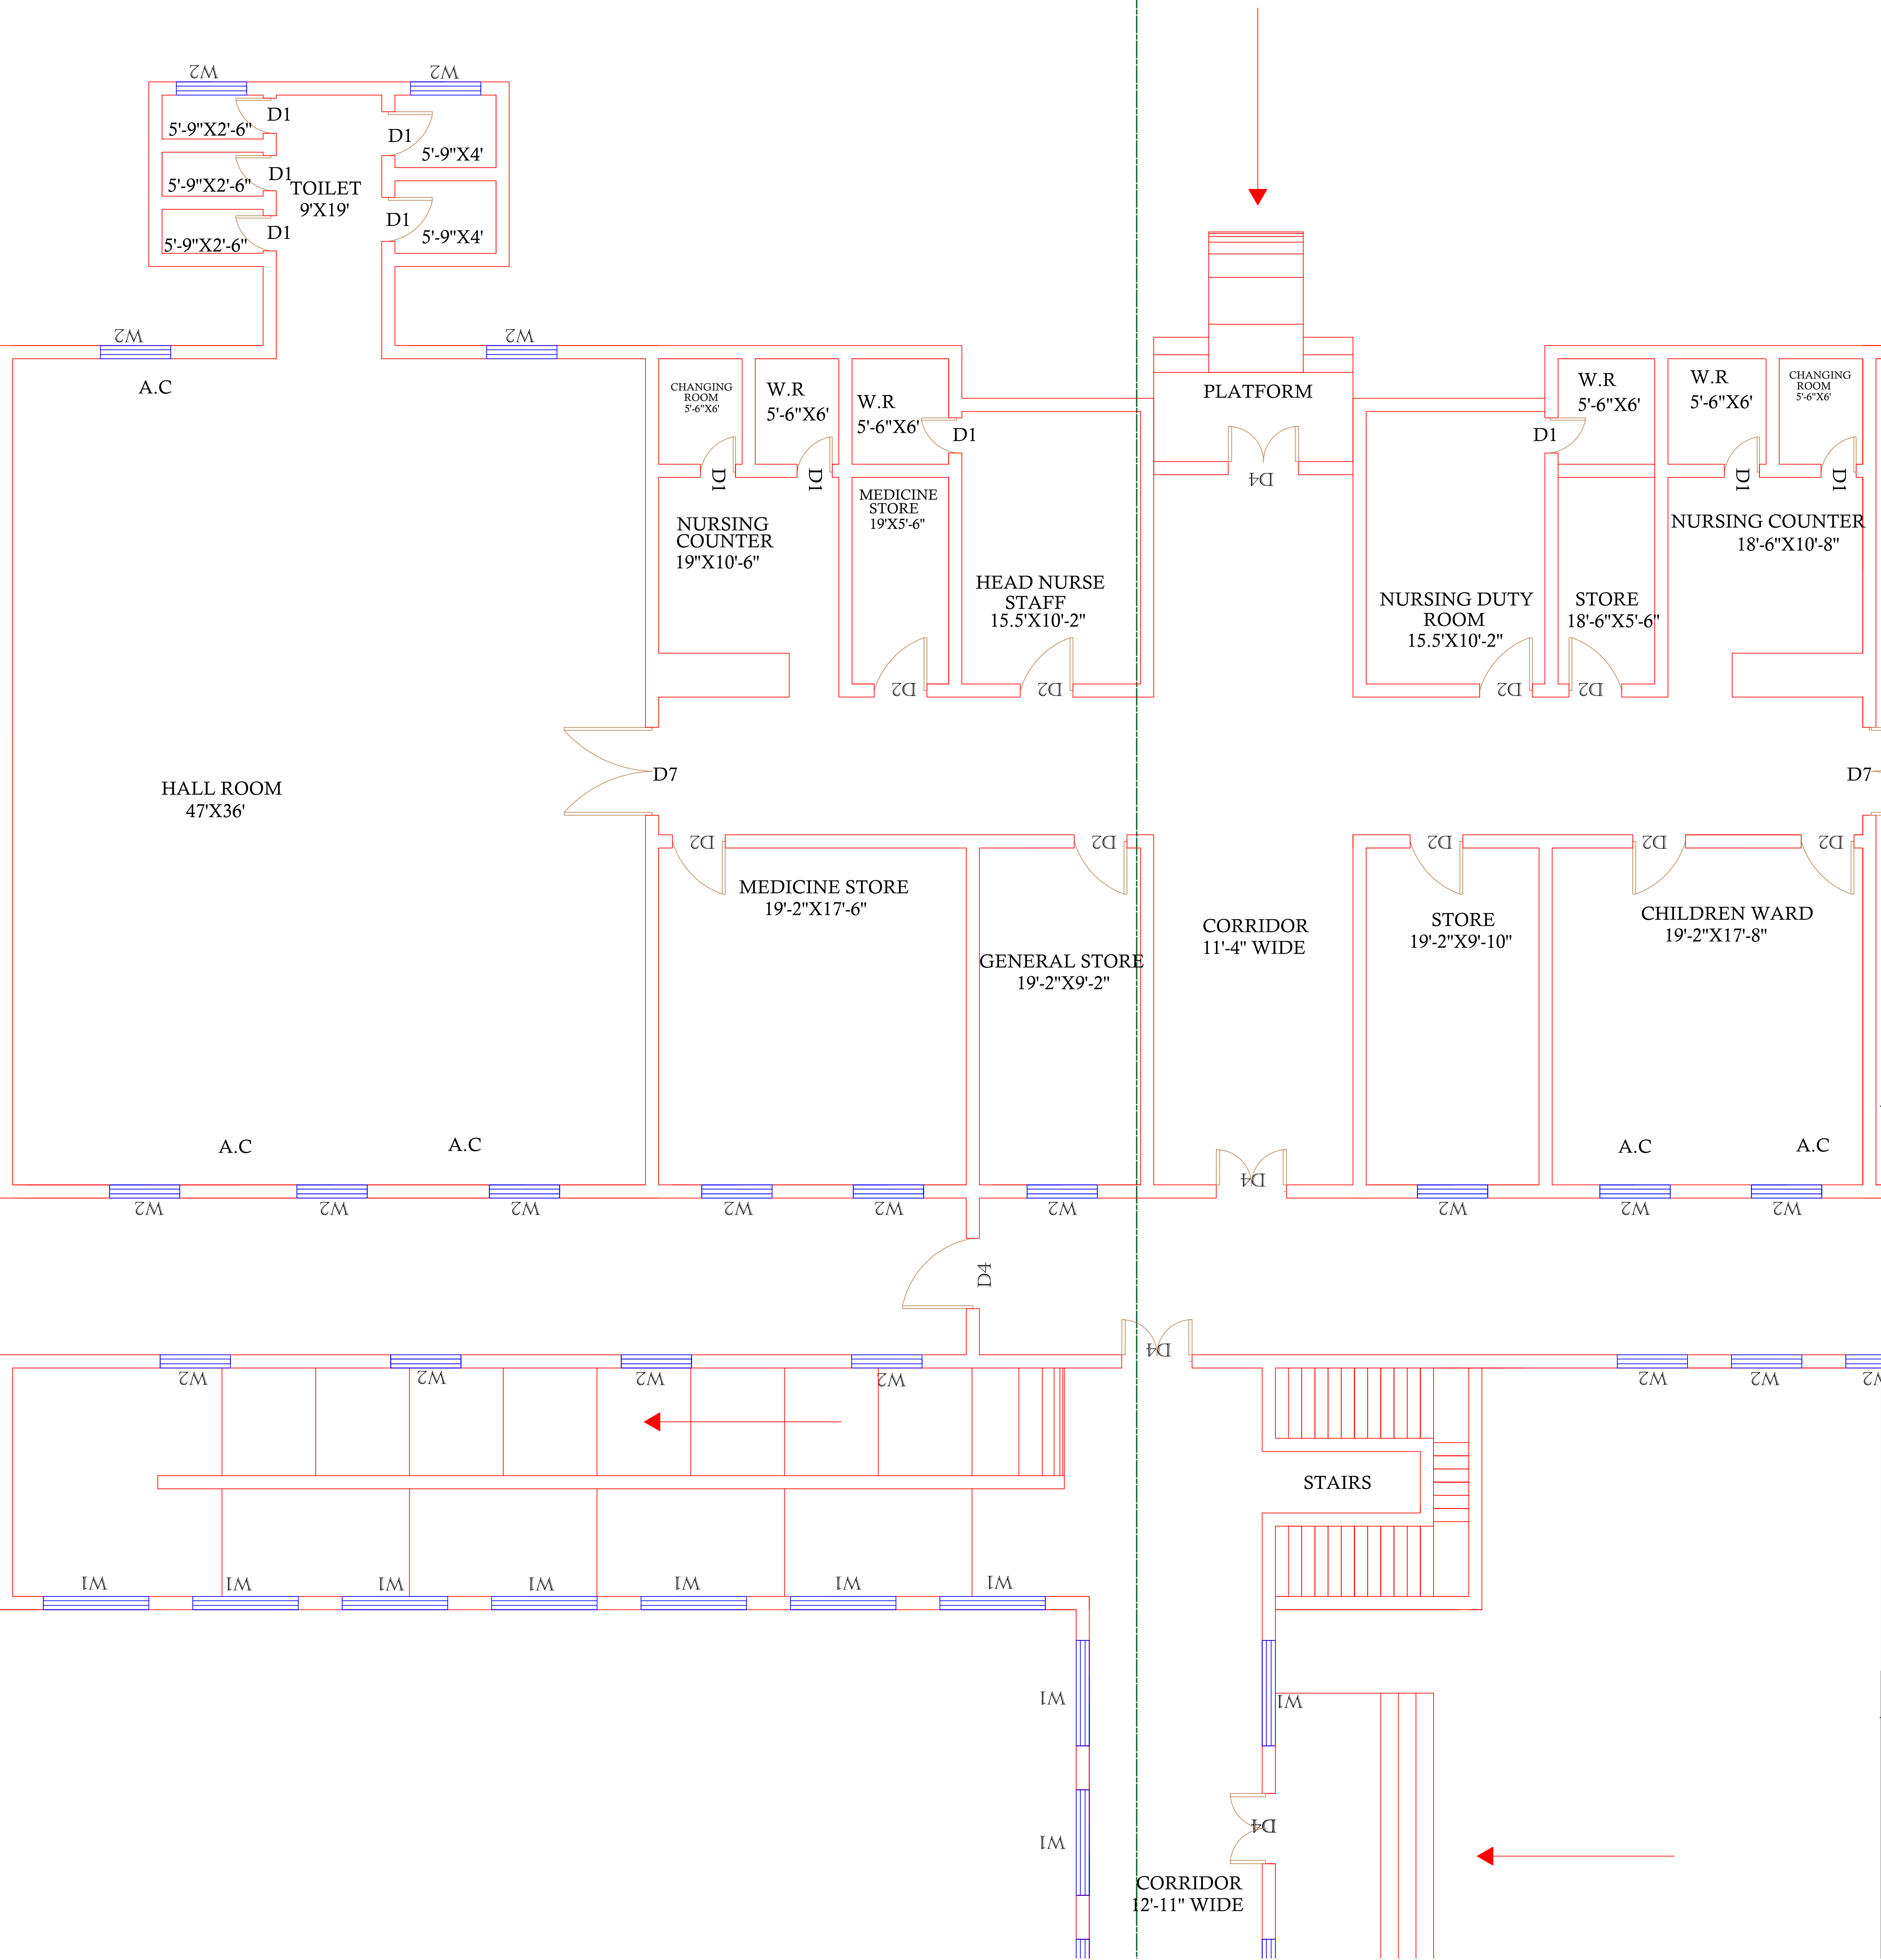

Legends:

RESIDENTIAL AREA	
ROAD	
WALL	
POWER LINE	
OHT	
TREE	
MANHOLE	
TUBE WELL	
LIGHT POLE	
LAWNS	
EARTHEN AREAS	
ASPHALTS ROADS	
TOUGH PAVERS	
P.C.C /PLINTH PROTECTION	
BOUNDARY WALL	
TAP	
HAND PUMP	
BRICK PAVERS	
AIR CONDITIONER	
TUBE LIGHT	
FAN	
ROOF LIGHT	
BULB	

AREA	
AREA WITHIN BOUNDARY WALL	333119.11 SFT
AREA OF CLINICAL BLOCK	21383.63
PLINTH AREA OF BLOCK	SFT

OPENING SCHEDULE OF DOORS AND WINDOWS					
DOORS	WIDTH	HEIGHT	WINDOWS	WIDTH	HEIGHT
D1	2'-6"	7'-0"	W1	2'-6"	2'-6"
D2	3'-0"	7'-0"	W2	3'-0"	3'-0"
D3	3'-6"	7'-0"	W3	4'-0"	4'-0"
D4	4'-0"	7'-0"	W4	5'-0"	5'-0"
D5	5'-0"	7'-0"	W5	6'-0"	6'-0"
D6	6'-0"	7'-0"	W6	8'-0"	8'-0"
D7	7'-0"	7'-0"	W7	9'-0"	9'-0"
D8	8'-0"	7'-0"	V1		
D9			V2		

Client:



GOVERNMENT OF THE PUNJAB
PRIMARY & SECONDARY
HEALTHCARE DEPARTMENT

Project:

CAD MAPPING OF TEHSIL
HEAD QUARTER HOSPITALS,
PUNJAB

Consultant:



SKAFS CONSULTANT (Pvt.) Limited
ENGINEERING AND ENVIRONMENT CONSULTANT


Drawing Title:

THQ PIPLAN
HOSPITAL CLINICAL BLOCK
PART 1

Authorized By: SKAFS	Reviewed By Co-Team Leader	Scale:
Prepared By: CAD TEAMS	Date: FEB, 2017	
Drawing No. SKAFS/PIPLAN /09		

CLINICAL BLOCK OF THQ HOSPITAL PIPLAN

GROUND FLOOR (PART 2)

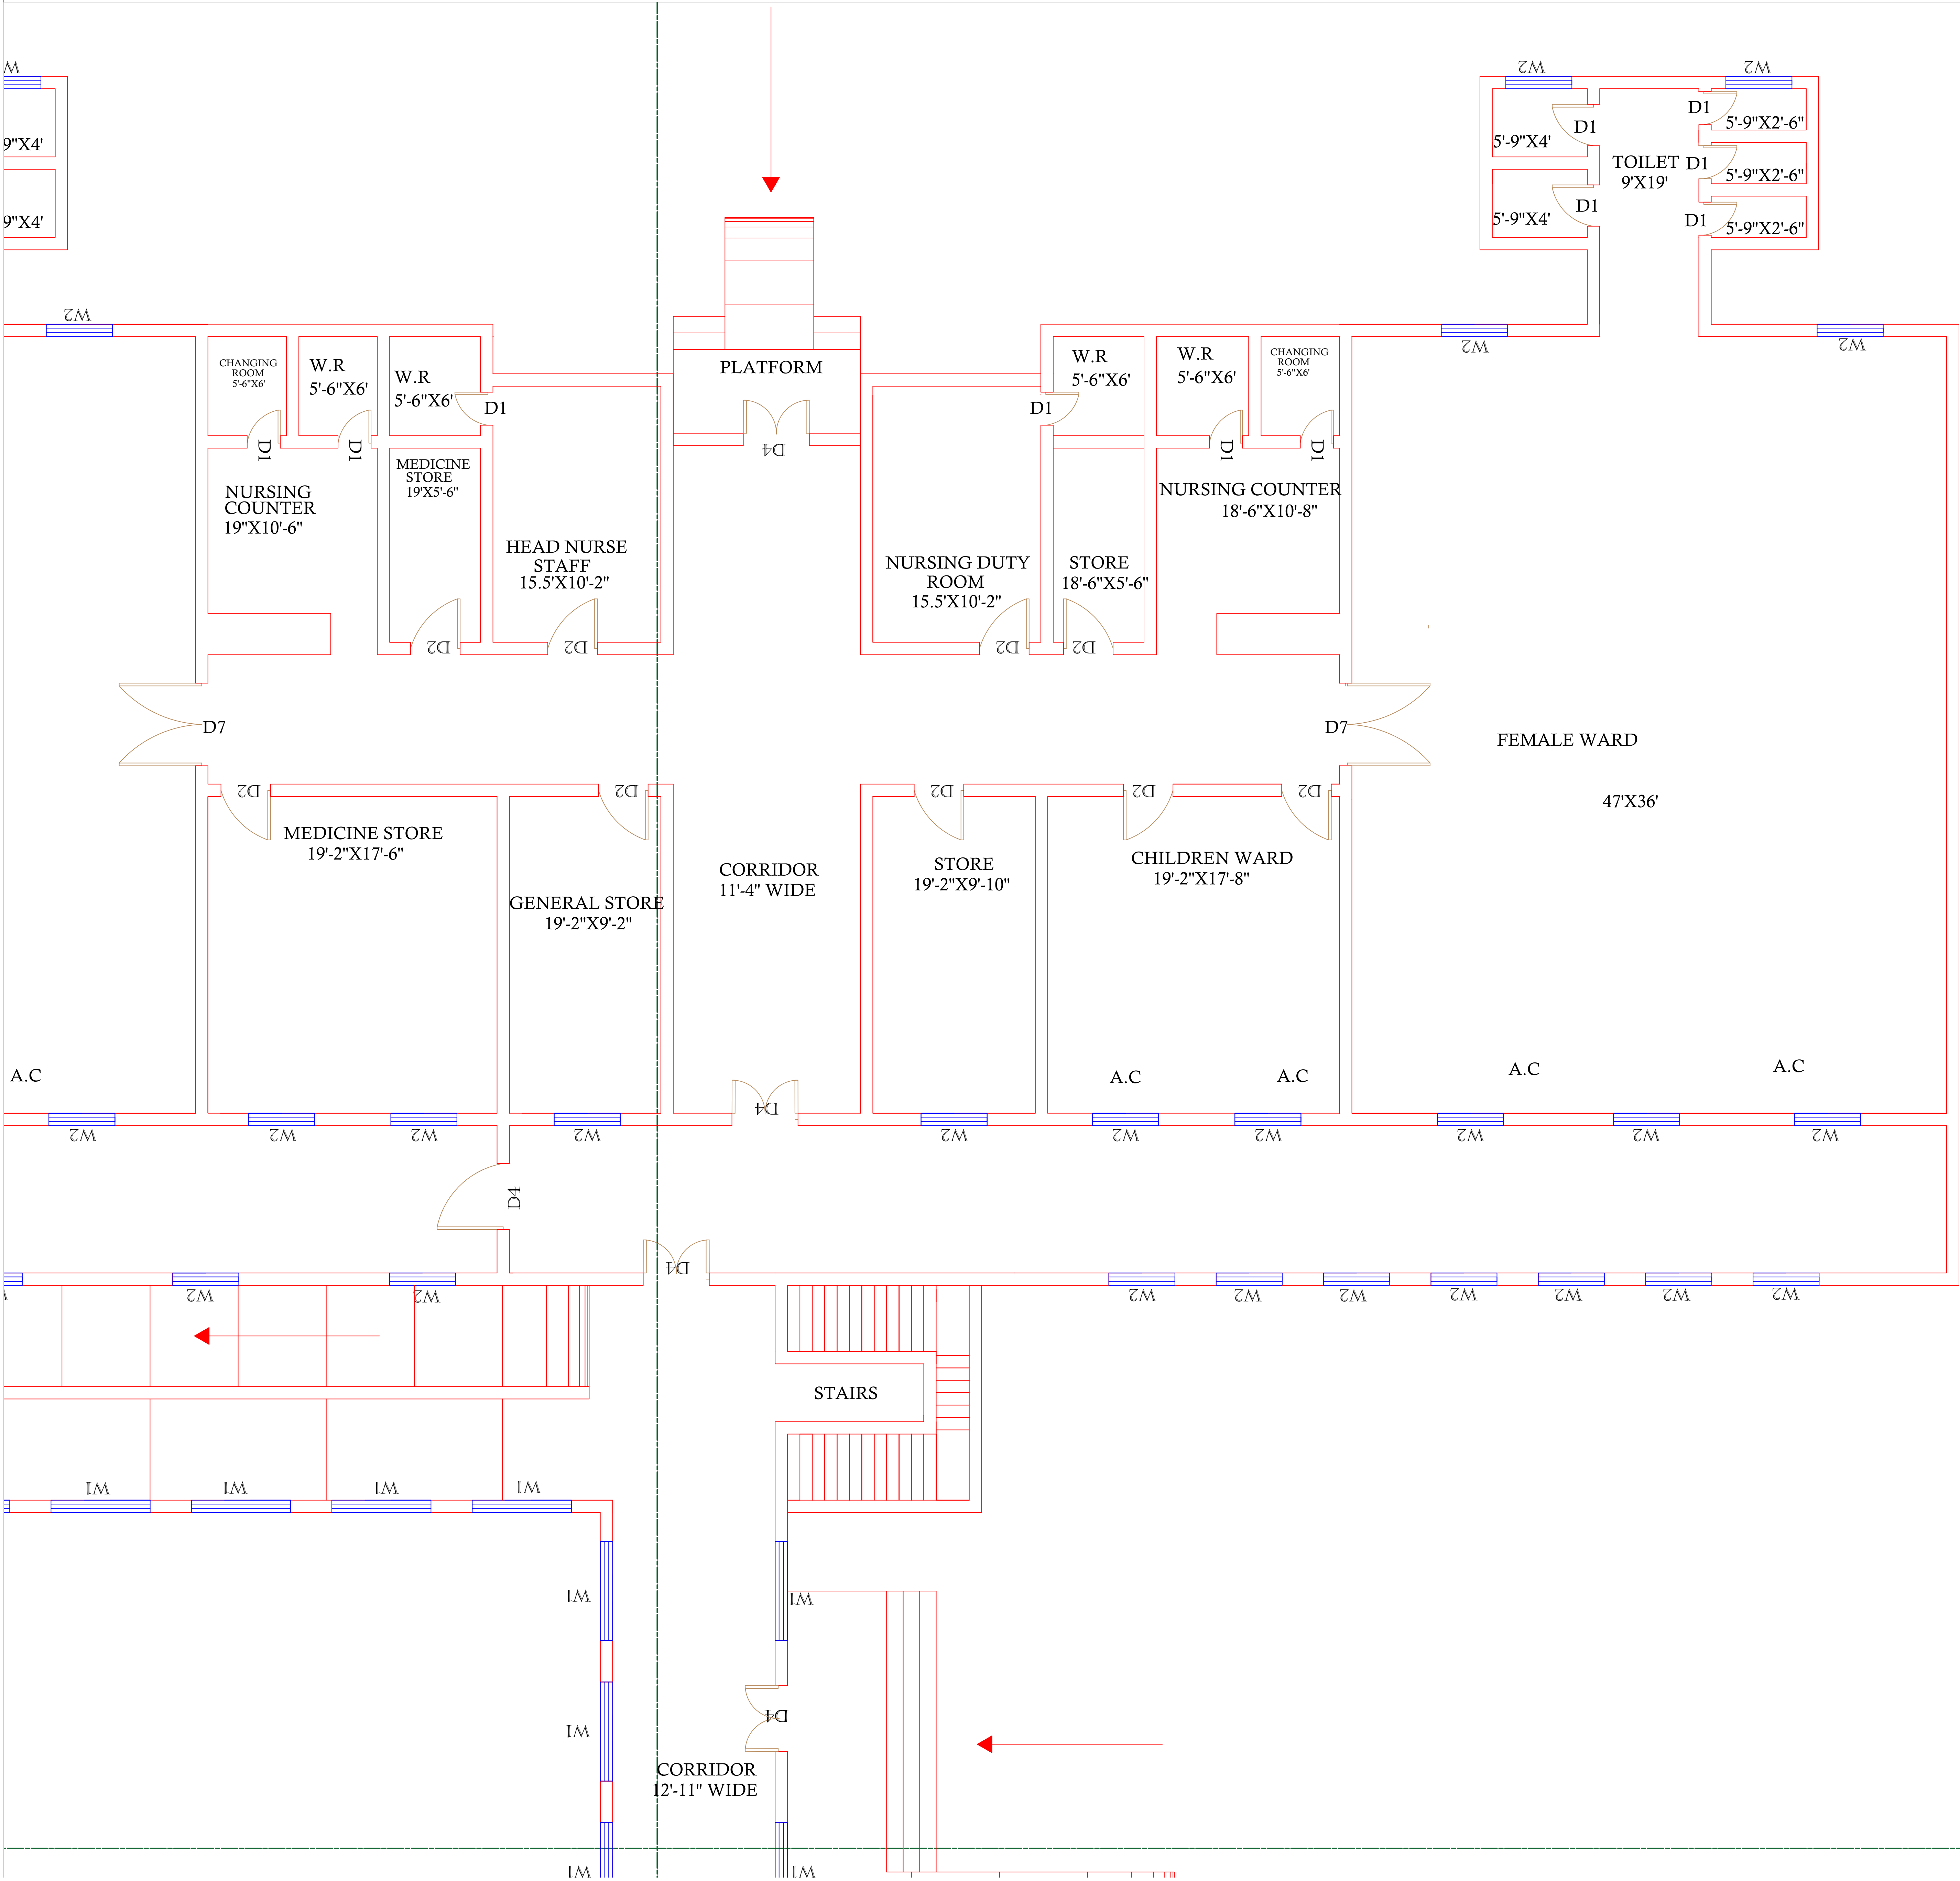

Legends:

RESIDENTIAL AREA	
ROAD	
WALL	
POWER LINE	
OHT	
TREE	
MANHOLE	
TUBE WELL	
LIGHT POLE	
LAWNS	
EARTHEN AREAS	
ASPHALTS ROADS	
TOUGH PAVERS	
P.C.C. /PLINTH PROTECTION	
BOUNDARY WALL	
TAP	
HAND PUMP	
BRICK PAVERS	
AIR CONDITIONER	
TUBE LIGHT	
FAN	
ROOF LIGHT	
BULB	

AREA	
AREA WITHIN BOUNDARY WALL	333119.11 SFT
AREA OF CLINICAL BLOCK	21383.63
PLINTH AREA OF BLOCK	SFT

OPENING SCHEDULE OF DOORS AND WINDOWS					
DOORS	WIDTH	HEIGHT	WINDOWS	WIDTH	HEIGHT
D1	2'-6"	7'-0"	W1	2'-6"	2'-6"
D2	3'-0"	7'-0"	W2	3'-0"	3'-0"
D3	3'-6"	7'-0"	W3	4'-0"	4'-0"
D4	4'-0"	7'-0"	W4	5'-0"	5'-0"
D5	5'-0"	7'-0"	W5	6'-0"	6'-0"
D6	6'-0"	7'-0"	W6	8'-0"	8'-0"
D7	7'-0"	7'-0"	W7	9'-0"	9'-0"
D8	8'-0"	7'-0"	V1		
D9			V2		

Client:



GOVERNMENT OF THE PUNJAB
PRIMARY & SECONDARY
HEALTHCARE DEPARTMENT

Project:

CAD MAPPING OF TEHSIL
HEAD QUARTER HOSPITALS,
PUNJAB

Consultant:



SKAFS CONSULTANT (Pvt.) Limited
ENGINEERING AND ENVIRONMENT CONSULTANT


Drawing Title:

THQ PIPLAN
HOSPITAL CLINICAL BLOCK
PART 2

Authorized By: SKAFS	Reviewed By Co-Team Leader	Scale:
Prepared By: CAD TEAMS	Date: FEB, 2017	
Drawing No.		SKAFS/PIPLAN /10

CLINICAL BLOCK OF THQ HOSPITAL PIPLAN

GROUND FLOOR (PART 3)

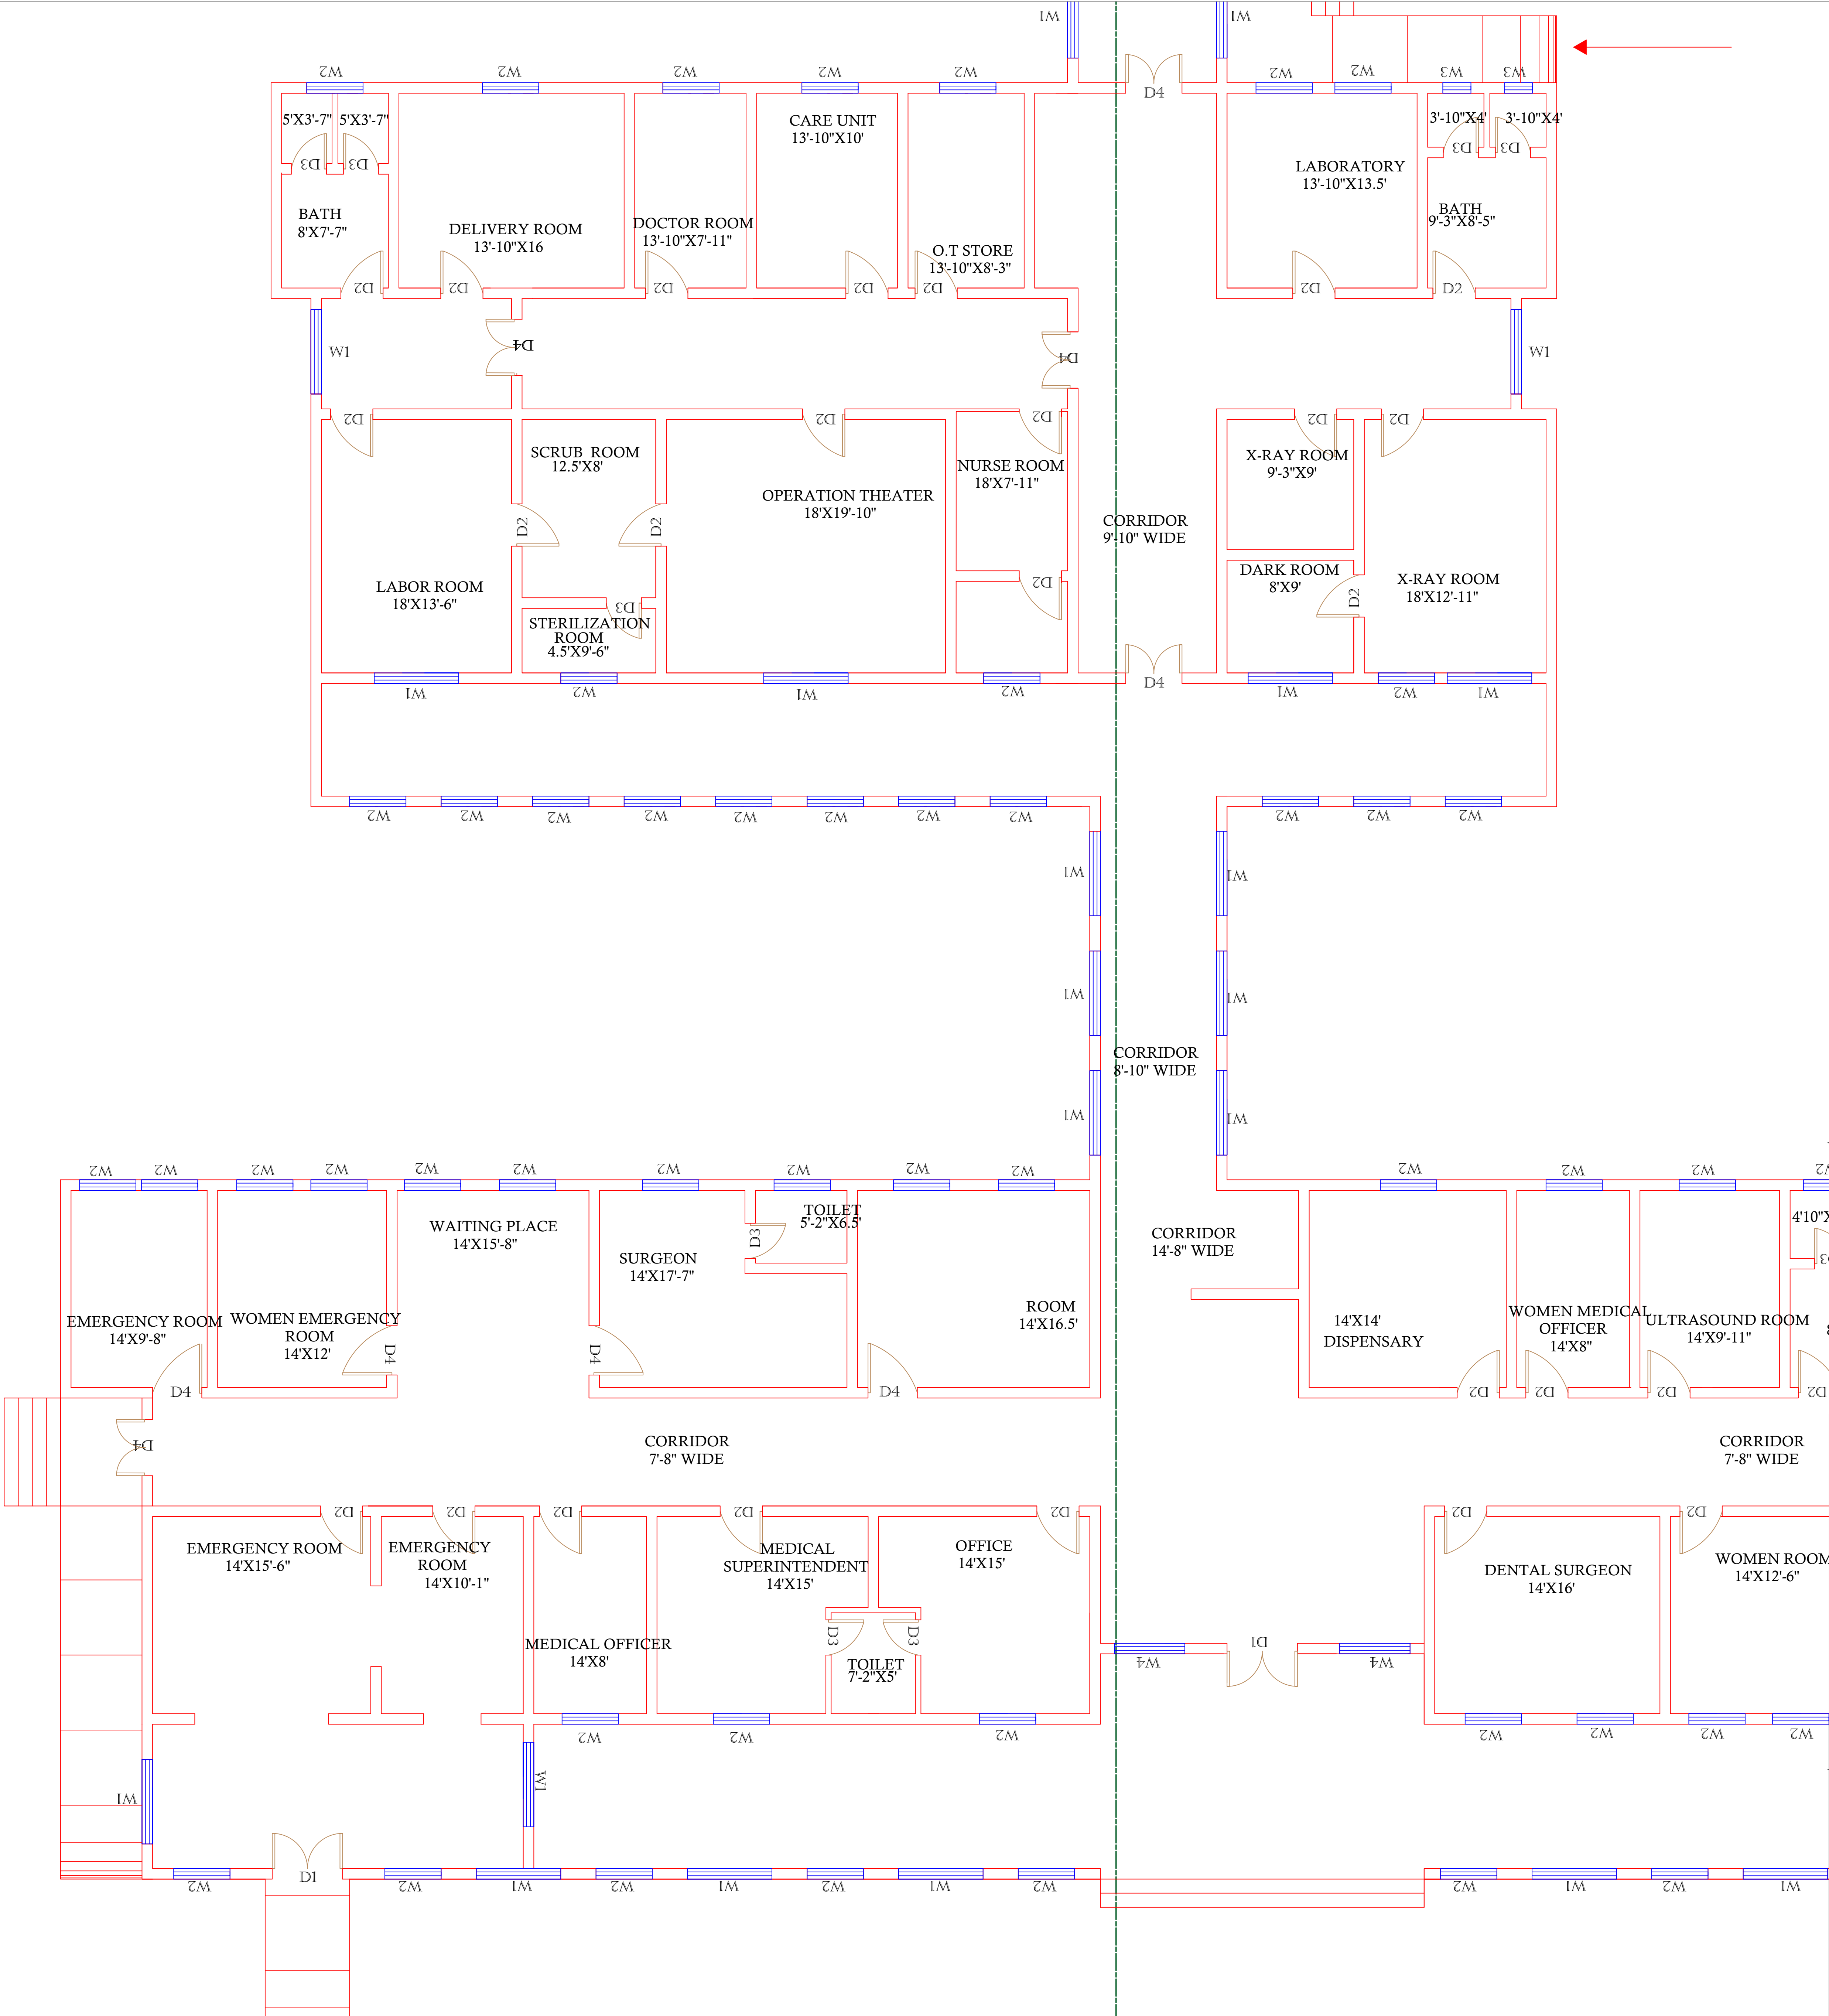

Legends:

RESIDENTIAL AREA	
ROAD	
WALL	
POWER LINE	
OHT	
TREE	
MANHOLE	
TUBE WELL	
LIGHT POLE	
LAWNS	
EARTHEN AREAS	
ASPHALTS ROADS	
TOUGH PAVERS	
P.C.C /PLINTH PROTECTION	
BOUNDARY WALL	
TAP	
HAND PUMP	
BRICK PAVERS	
AIR CONDITIONER	
TUBE LIGHT	
FAN	
ROOF LIGHT	
BULB	

AREA	
AREA WITHIN BOUNDARY WALL	333119.11 SFT
AREA OF CLINICAL BLOCK	21383.63 SFT
PLINTH AREA OF BLOCK	SFT

OPENING SCHEDULE OF DOORS AND WINDOWS					
DOORS	WIDTH	HEIGHT	WINDOWS	WIDTH	HEIGHT
D1	2'-6"	7'-0"	W1	2'-6"	2'-6"
D2	3'-0"	7'-0"	W2	3'-0"	3'-0"
D3	3'-6"	7'-0"	W3	4'-0"	4'-0"
D4	4'-0"	7'-0"	W4	5'-0"	5'-0"
D5	5'-0"	7'-0"	W5	6'-0"	6'-0"
D6	6'-0"	7'-0"	W6	8'-0"	8'-0"
D7	7'-0"	7'-0"	W7	9'-0"	9'-0"
D8	8'-0"	7'-0"	V1		
D9			V2		

Client:

GOVERNMENT OF THE PUNJAB
PRIMARY & SECONDARY
HEALTHCARE DEPARTMENT

Project:

CAD MAPPING OF TEHSIL
HEAD QUARTER HOSPITALS,
PUNJAB

Consultant:

SKAFS CONSULTANT (Pvt.) Limited
ENGINEERING AND ENVIRONMENT CONSULTANT

Drawing Title:


THQ PIPLAN
HOSPITAL CLINICAL BLOCK
PART 3

Authorized By: SKAFS	Reviewed By Co-Team Leader	Scale:
Prepared By: CAD TEAMS	Date: FEB, 2017	
Drawing No.		

SKAFS/PIPLAN /11

CLINICAL BLOCK OF THQ HOSPITAL PIPLAN

GROUND FLOOR (PART 4)

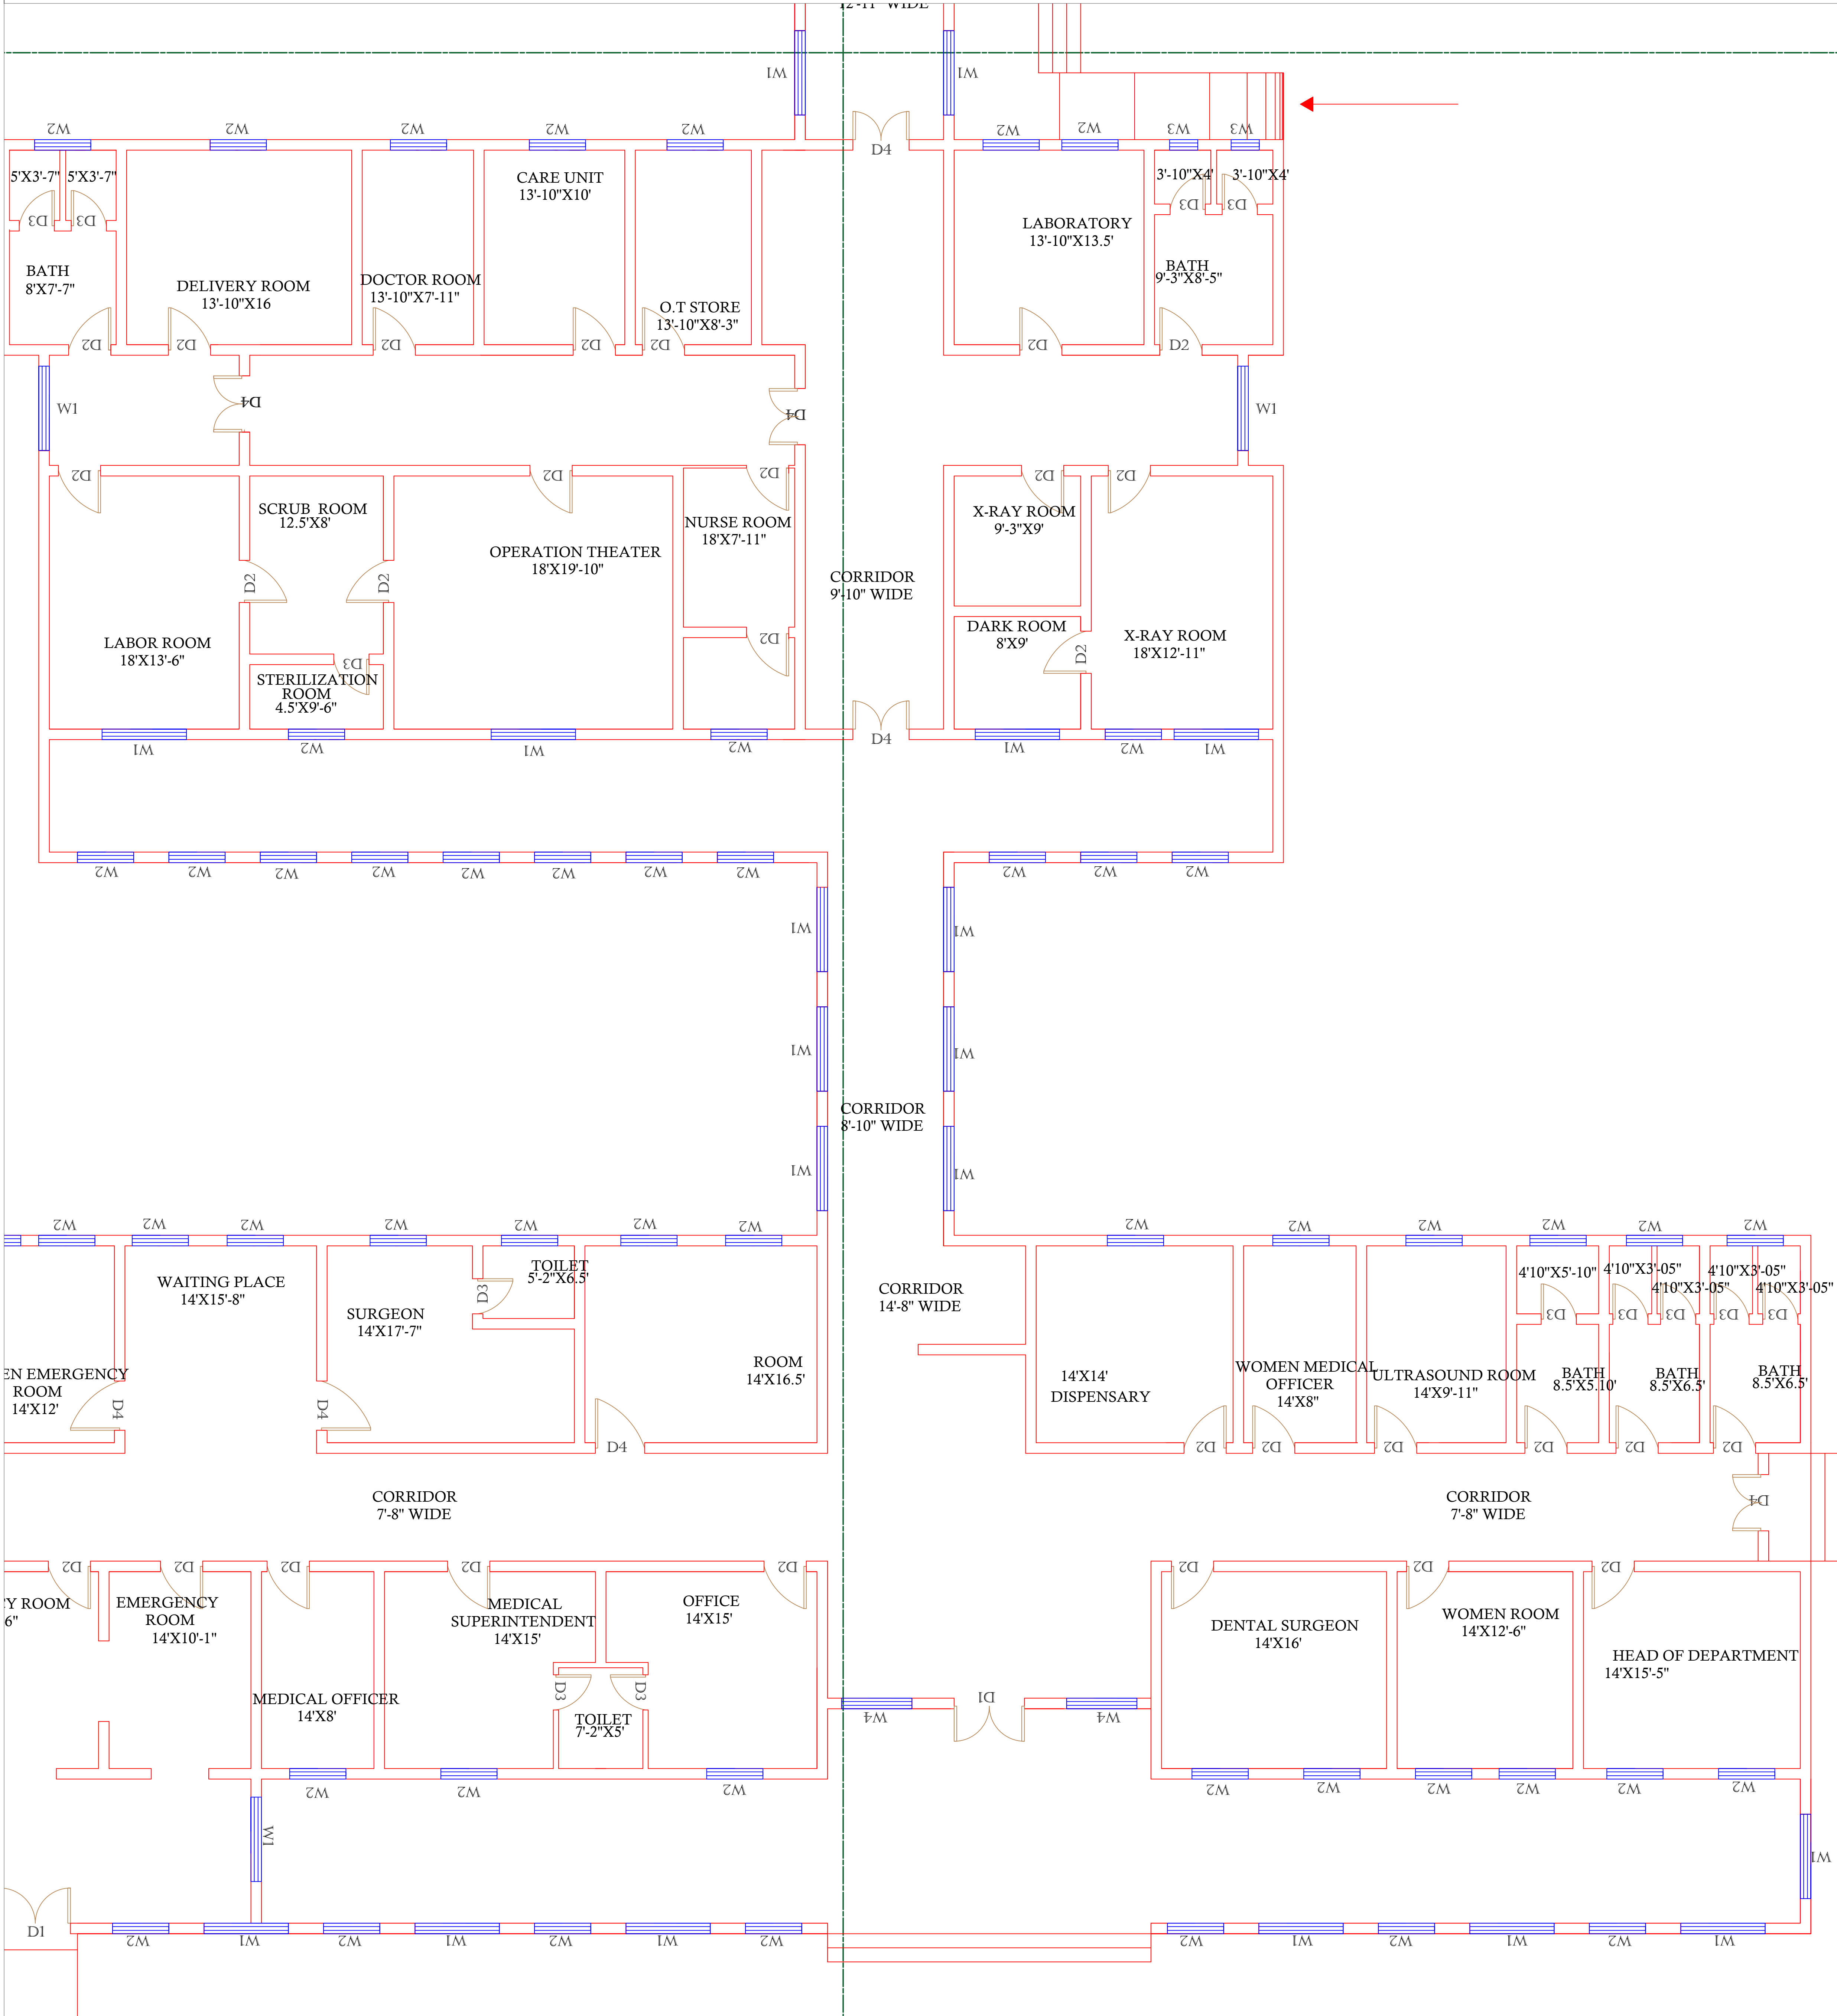

Legends:

RESIDENTIAL AREA	
ROAD	
WALL	
POWER LINE	
OHT	
TREE	
MANHOLE	
TUBE WELL	
LIGHT POLE	
LAWNS	
EARTHEN AREAS	
ASPHALTS ROADS	
TOUGH PAVERS	
P.C.C /PLINTH PROTECTION	
BOUNDARY WALL	
TAP	
HAND PUMP	
BRICK PAVERS	
AIR CONDITIONER	
TUBE LIGHT	
FAN	
ROOF LIGHT	
BULB	

AREA	
AREA WITHIN BOUNDARY WALL	333119.11 SFT
AREA OF CLINICAL BLOCK	21383.63
PLINTH AREA OF BLOCK	SFT

OPENING SCHEDULE OF DOORS AND WINDOWS					
DOORS	WIDTH	HEIGHT	WINDOWS	WIDTH	HEIGHT
D1	2'-6"	7'-0"	W1	2'-6"	2'-6"
D2	3'-0"	7'-0"	W2	3'-0"	3'-0"
D3	3'-6"	7'-0"	W3	4'-0"	4'-0"
D4	4'-0"	7'-0"	W4	5'-0"	5'-0"
D5	5'-0"	7'-0"	W5	6'-0"	6'-0"
D6	6'-0"	7'-0"	W6	8'-0"	8'-0"
D7	7'-0"	7'-0"	W7	9'-0"	9'-0"
D8	8'-0"	7'-0"	V1		
D9			V2		

Client:



GOVERNMENT OF THE PUNJAB
PRIMARY & SECONDARY
HEALTHCARE DEPARTMENT

Project:

CAD MAPPING OF TEHSIL
HEAD QUARTER HOSPITALS,
PUNJAB

Consultant:




SKAFS CONSULTANT (Pvt.) Limited
ENGINEERING AND ENVIRONMENT CONSULTANT

Drawing Title: THQ PIPLAN HOSPITAL CLINICAL BLOCK PART 4		
Authorized By: SKAFS	Reviewed By Co-Team Leader	Scale:
Prepared By: CAD TEAMS	Date: FEB, 2017	
Drawing No. SKAFS/PIPLAN /12		

ELECTRICAL LAYOUT PLAN OF THQ HOSPITAL PIPLAN

GROUND FLOOR

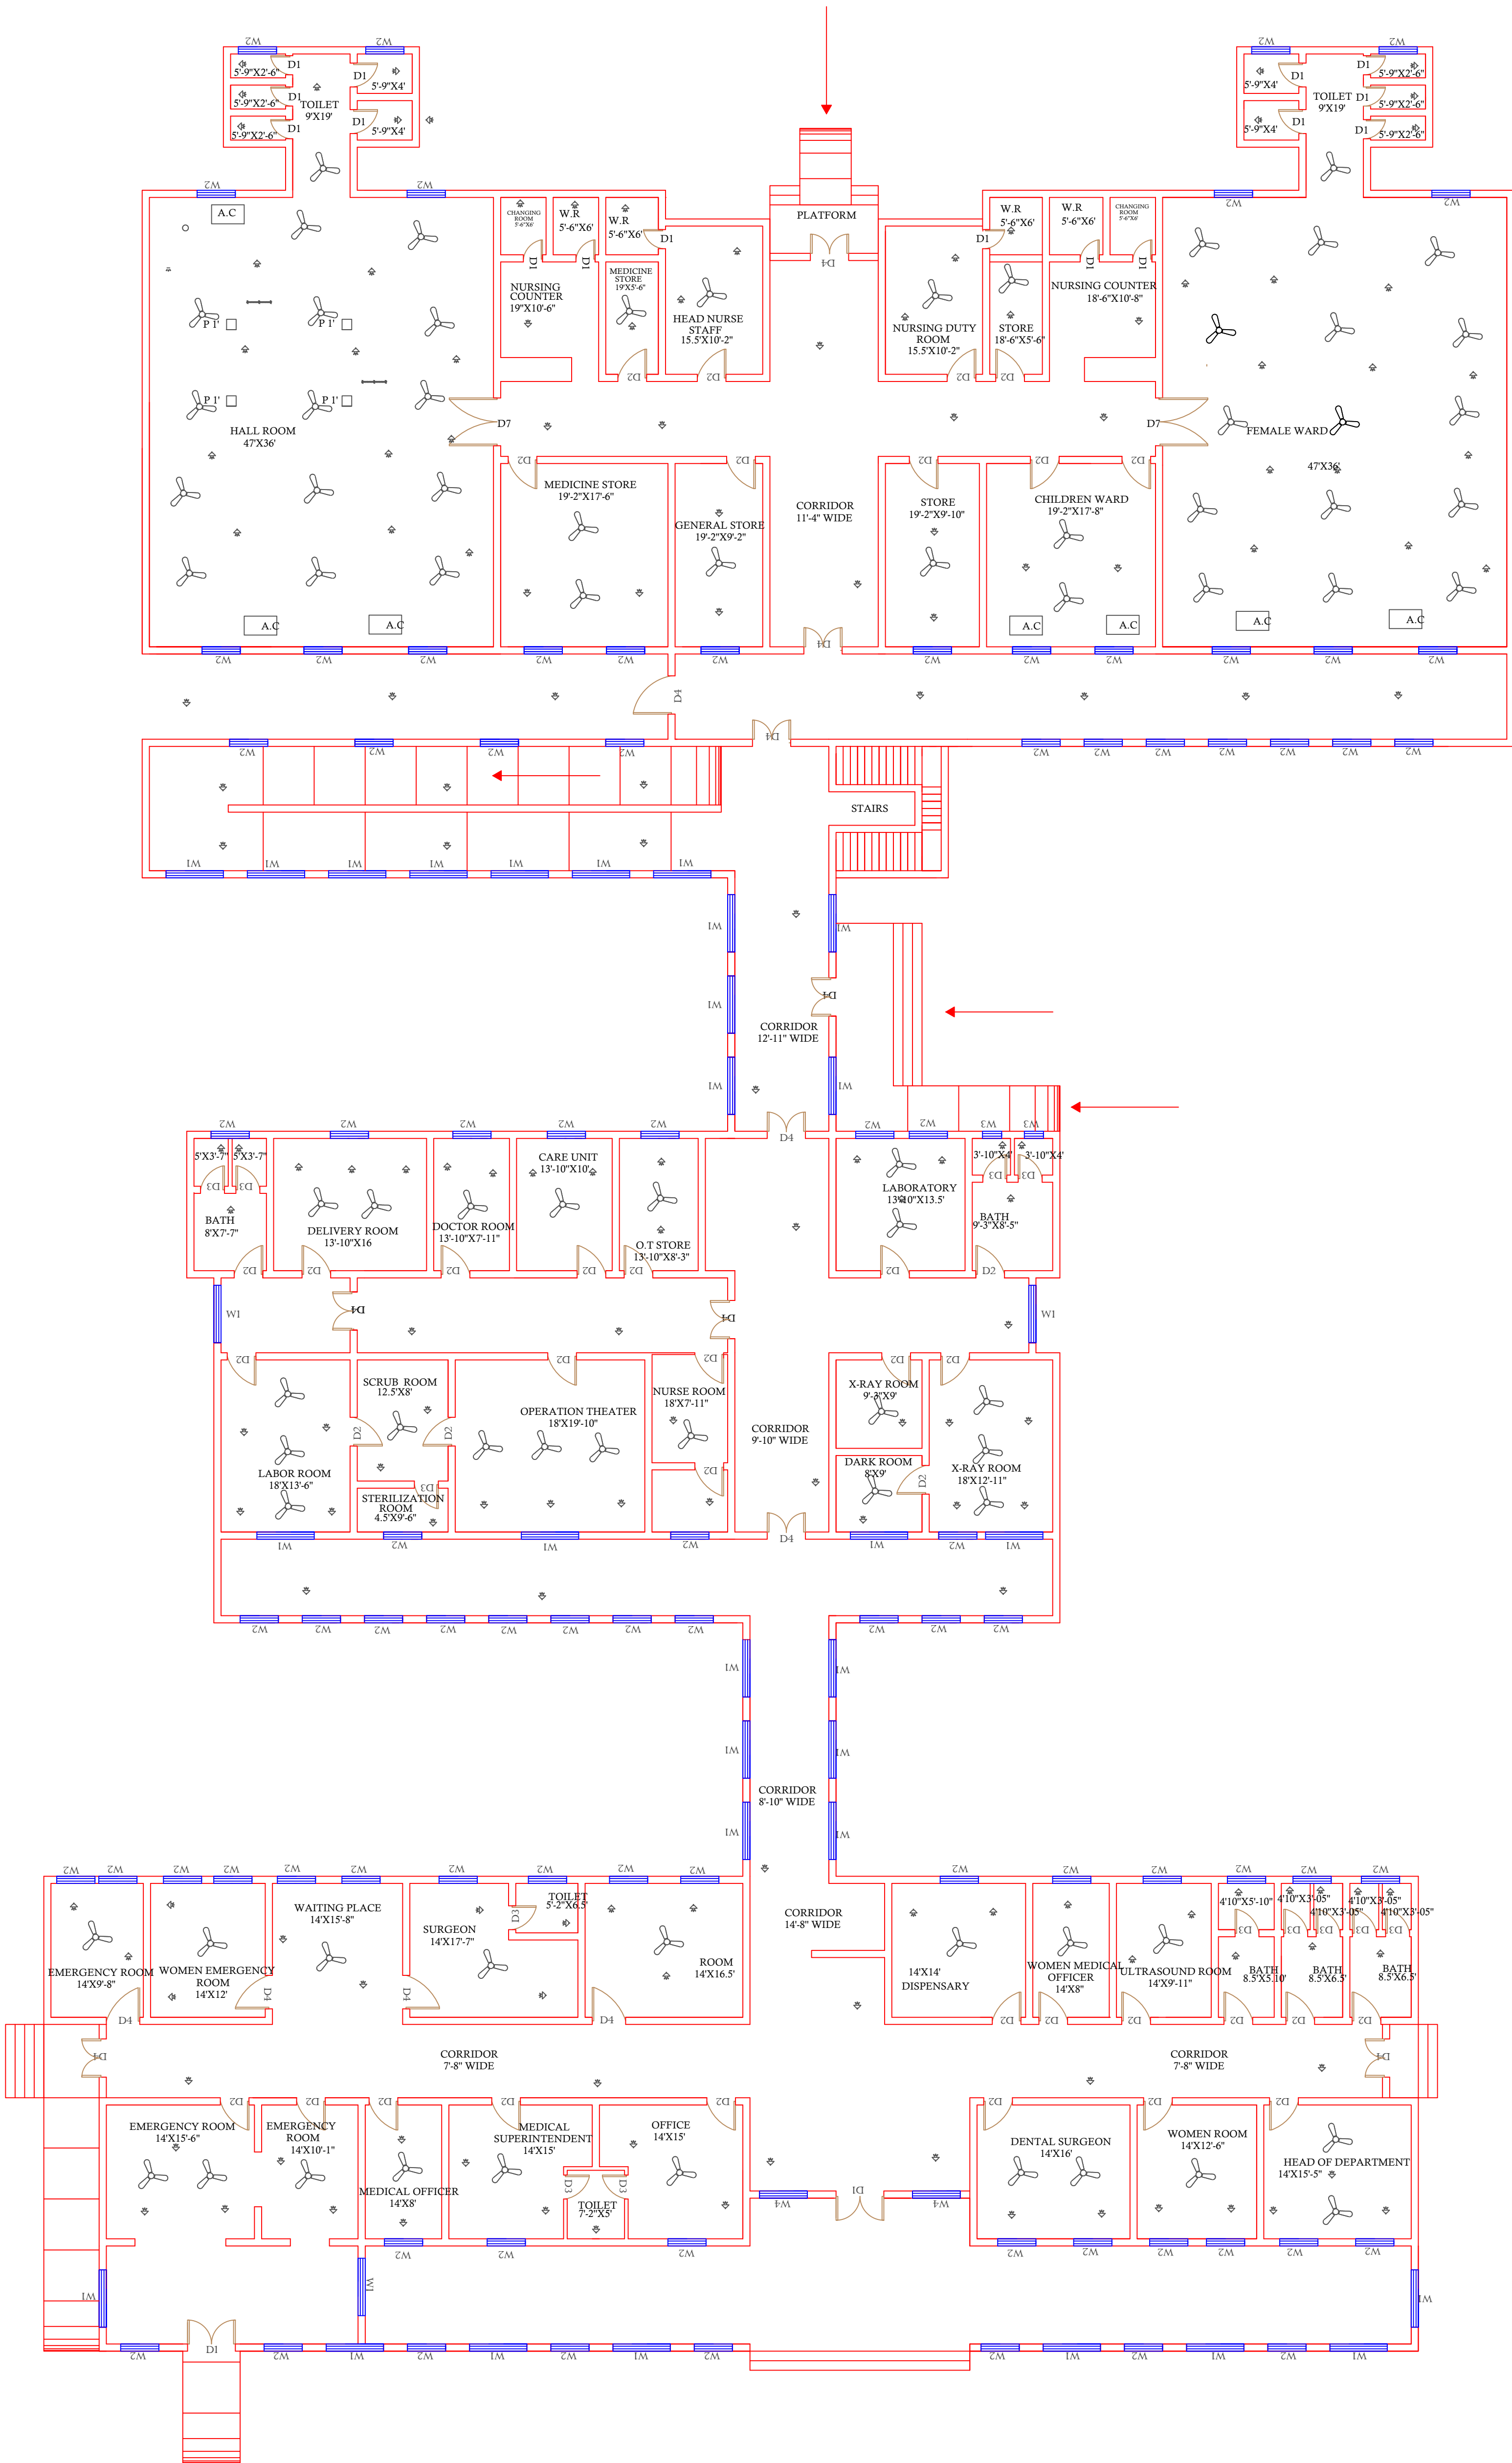

Legends:

RESIDENTIAL AREA	
ROAD	
WALL	
POWER LINE	
OHT	
TREE	
MANHOLE	
TUBE WELL	
LIGHT POLE	
LAWNS	
EARTHEN AREAS	
ASPHALTS ROADS	
TOUGH PAVERS	
P.C.C /PLINTH PROTECTION	
BOUNDARY WALL	
TAP	
HAND PUMP	
BRICK PAVERS	
AIR CONDITIONER	
TUBE LIGHT	
FAN	
ROOF LIGHT	
BULB	

AREA	
AREA WITHIN BOUNDARY WALL	333119.11 SFT
AREA OF CLINICAL BLOCK	21383.63 SFT
PLINTH AREA OF BLOCK	SFT

OPENING SCHEDULE OF DOORS AND WINDOWS					
DOORS	WIDTH	HEIGHT	WINDOWS	WIDTH	HEIGHT
D1	2'-6"	7'-0"	W1	2'-6"	2'-6"
D2	3'-0"	7'-0"	W2	3'-0"	3'-0"
D3	3'-6"	7'-0"	W3	4'-0"	4'-0"
D4	4'-0"	7'-0"	W4	5'-0"	5'-0"
D5	5'-0"	7'-0"	W5	6'-0"	6'-0"
D6	6'-0"	7'-0"	W6	8'-0"	8'-0"
D7	7'-0"	7'-0"	W7	9'-0"	9'-0"
D8	8'-0"	7'-0"	V1		
D9			V2		

Client:



GOVERNMENT OF THE PUNJAB
PRIMARY & SECONDARY
HEALTHCARE DEPARTMENT

Project:

CAD MAPPING OF TEHSIL
HEAD QUARTER HOSPITALS,
PUNJAB

Consultant:



SKAFS CONSULTANT (Pvt.) Limited
ENGINEERING AND ENVIRONMENT CONSULTANT

Drawing Title:

THQ PIPLAN
ELECTRICAL LAYOUT
GROUND FLOOR

Authorized By: SKAFS	Reviewed By Co-Team Leader	Scale:
Prepared By: CAD TEAMS	Date: FEB, 2017	
Drawing No. SKAFS/PIPLAN /13		