


MASTER PLAN OF THQ HOSPITAL SHABBIR SHARIF

PART 1

PART 2

PART 3

PART 4

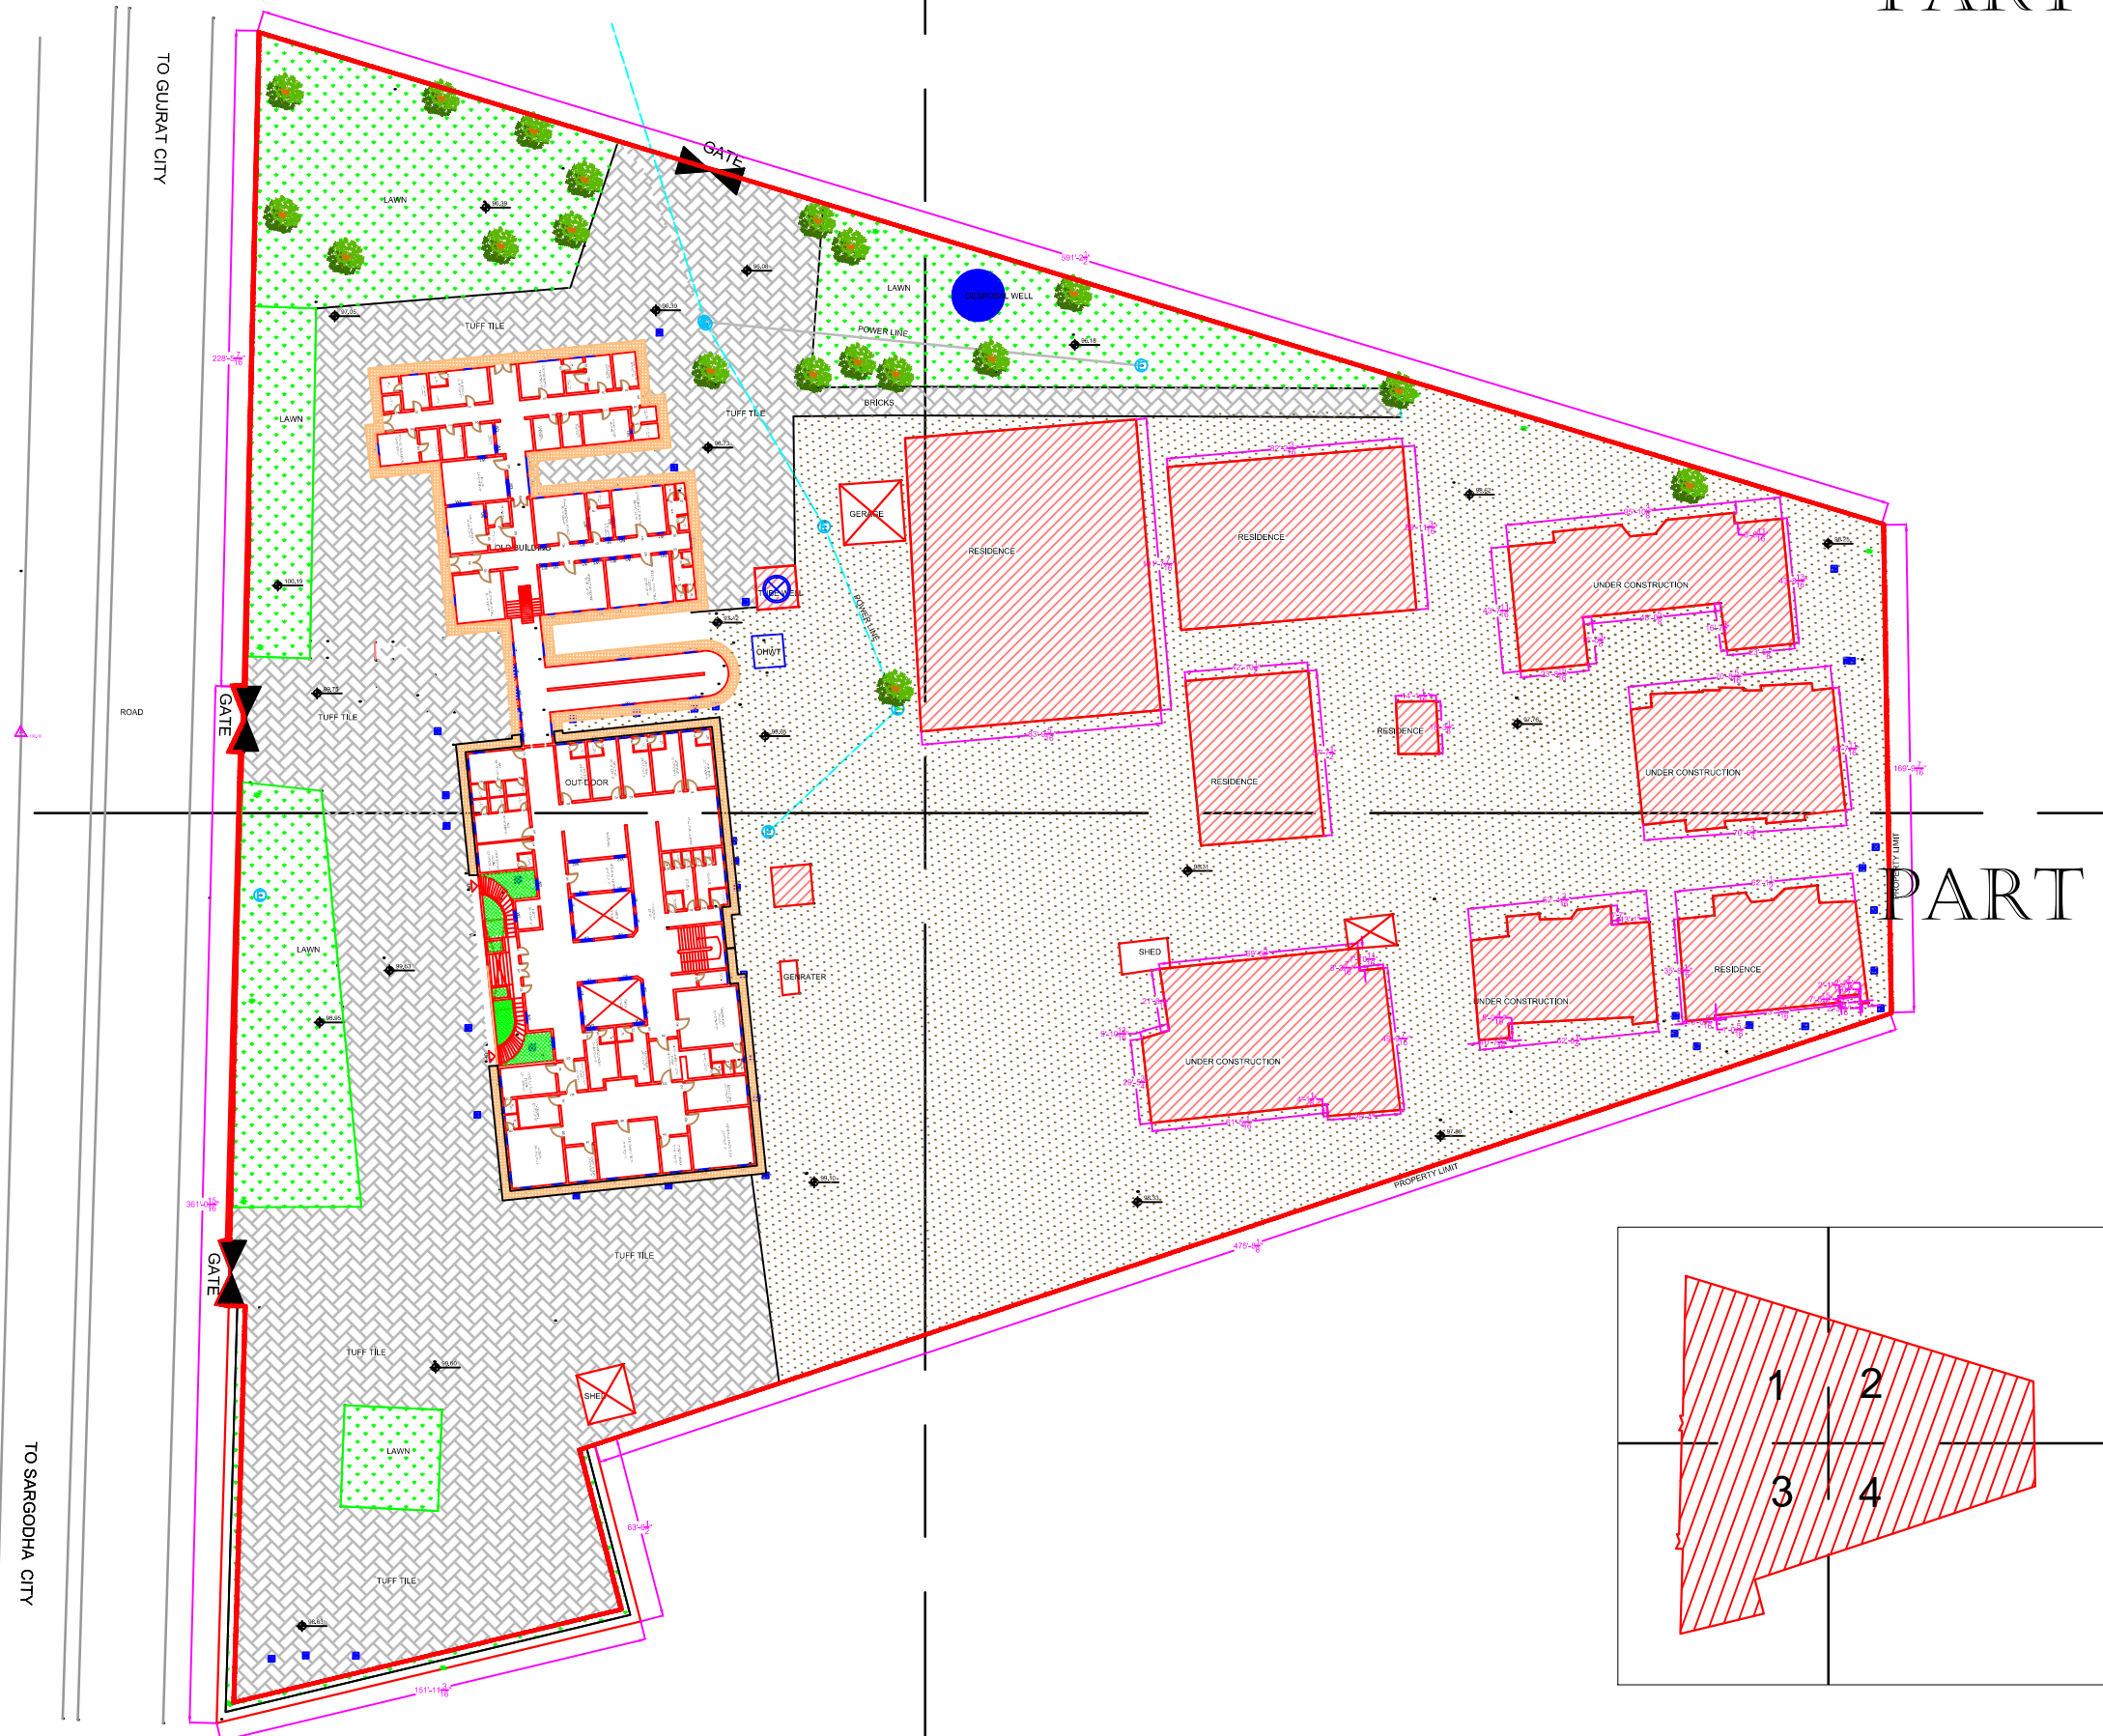

Legends:

| | |
|---------------------------|--|
| Residential Area | |
| Road | |
| Wall | |
| Power Line | |
| OHT | |
| Tree | |
| Man Hole | |
| Tube Well | |
| Light Pole | |
| Lawns | |
| Earthen Areas | |
| Asphalts Roads | |
| Tough Pavers | |
| P.C.C / Plinth Protection | |
| Boundary Wall | |
| Brick Pavers / Soling | |
| Drain | |
| Tap | |
| Hand Pump | |
| Air Conditioner | |
| Tube Light | |
| Fan | |
| Roof Light | |
| Bulb | |

| AREA | |
|---------------------------|---------------|
| AREA WITHIN BOUNDARY WALL | 210876.26 Sft |
| AREA OF CLINICAL BLOCK | 35635.8726Sft |
| PLINTH AREA OF BLOCK | 21845.8968Sft |


| OPENING SCHEDULE OF DOORS AND WINDOWS | | | | | |
|---------------------------------------|-------|--------|---------|-------|--------|
| DOORS | WIDTH | HEIGHT | WINDOWS | WIDTH | HEIGHT |
| D1 | 2'-0" | 7'-0" | W1 | 3'-0" | 5'-0" |
| D2 | 2'-6" | 7'-0" | W2 | 4'-0" | 4'-0" |
| D3 | 3'-0" | 7'-0" | W3 | 6'-0" | 6'-0" |
| D4 | 3'-6" | 7'-0" | W4 | 8'-0" | 8'-0" |
| D5 | 4'-0" | 7'-0" | W5 | 5'-0" | 5'-0" |
| D6 | 4'-6" | 7'-0" | W6 | | |
| D7 | 5'-0" | 7'-0" | W7 | | |
| D8 | 6'-0" | 7'-0" | V1 | 2'-0" | 2'-0" |
| D9 | 7'-0" | 7'-0" | V2 | | |

Project:
CAD MAPPING OF TEHSIL HEAD QUARTER HOSPITALS, PUNJAB

| | |
|---|--|
| Client: GOVERNMENT OF THE PUNJAB PRIMARY & SECONDARY HEALTHCARE DEPARTMENT | Consultant: SKAFS CONSULTANT (Pvt.) Limited ENGINEERING AND ENVIRONMENT CONSULTANT |
|---|--|


Drawing Title:
THQ SHABBIR SHARIF HOSPITAL MASTER PLAN

Drawing No. **SKAFS/SHABBIR SHARIF /03**

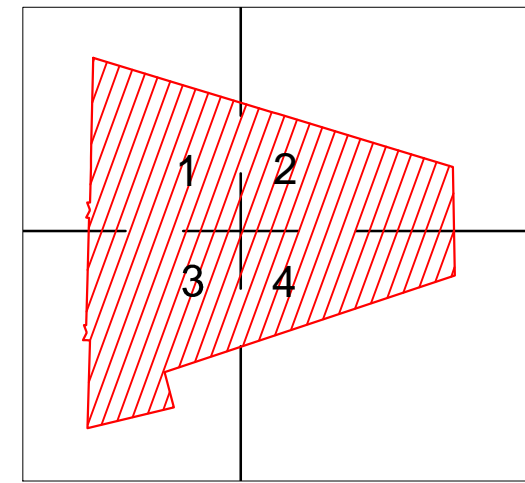


MASTER PLAN OF THQ HOSPITAL SHABBIR SHARIF

PART 1

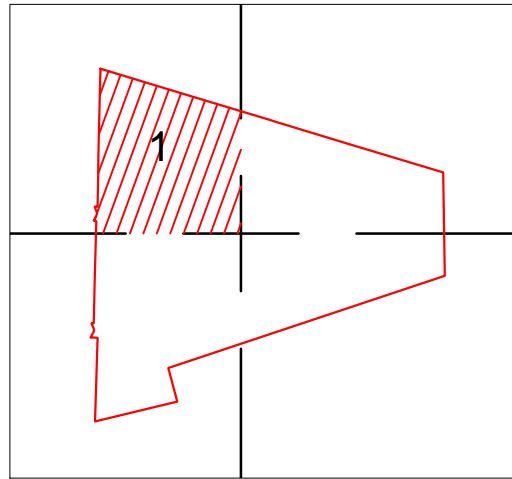

TO GURAT CITY

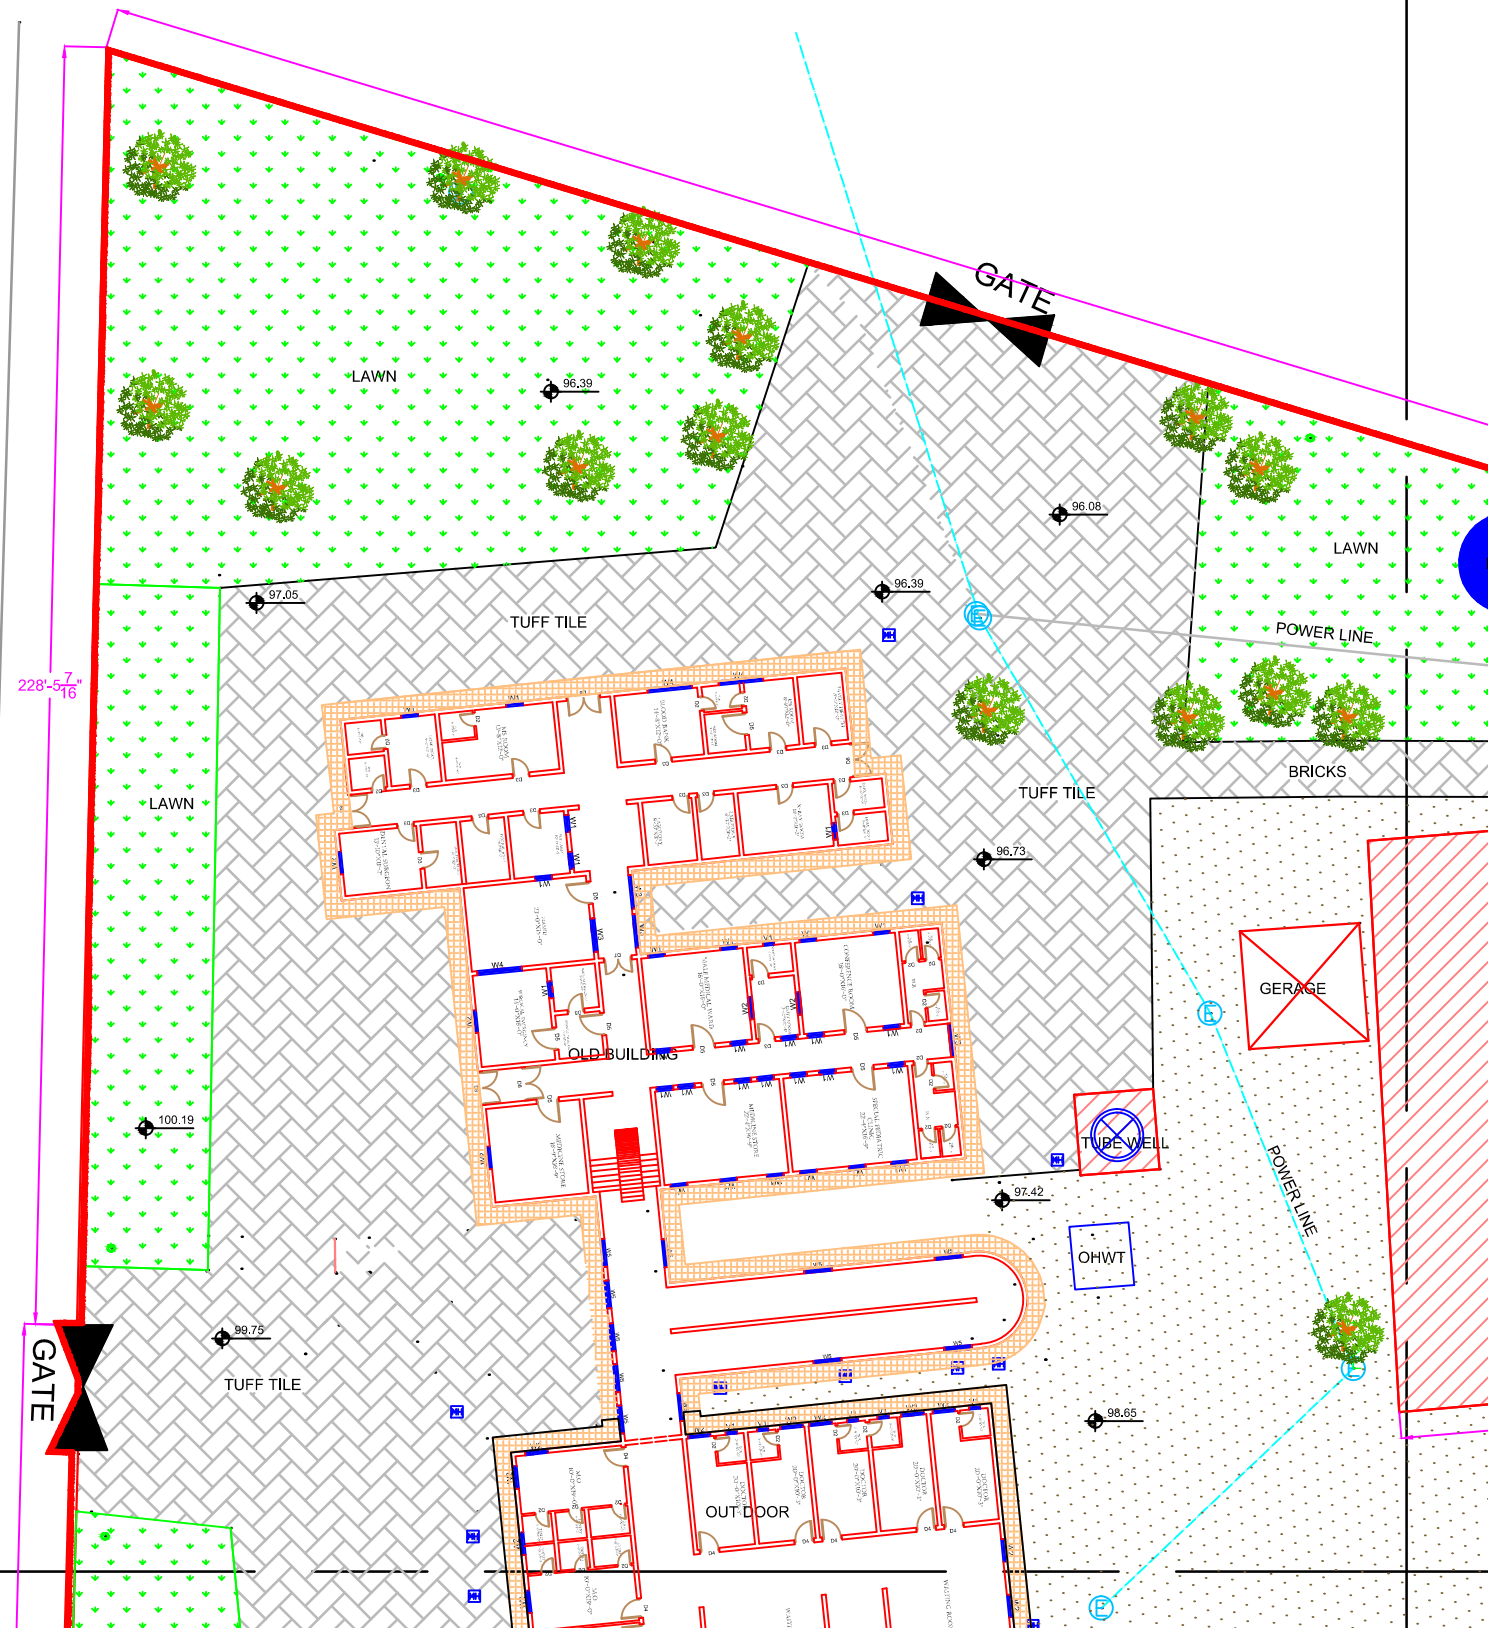

Legends:

| | |
|---------------------------|--|
| Residential Area | |
| Road | |
| Wall | |
| Power Line | |
| OHT | |
| Tree | |
| Man Hole | |
| Tube Well | |
| Light Pole | |
| Lawns | |
| Earthen Areas | |
| Asphalts Roads | |
| Tough Pavers | |
| P.C.C / Plinth Protection | |
| Boundary Wall | |
| Brick Pavers / Soling | |
| Drain | |
| Tap | |
| Hand Pump | |
| Air Conditioner | |
| Tube Light | |
| Fan | |
| Roof Light | |
| Bulb | |

| AREA | |
|---------------------------|---------------|
| AREA WITHIN BOUNDARY WALL | 210876.26 Sft |
| AREA OF CLINICAL BLOCK | 35635.8726Sft |
| PLINTH AREA OF BLOCK | 21845.8968Sft |

| OPENING SCHEDULE OF DOORS AND WINDOWS | | | | | |
|---------------------------------------|-------|--------|---------|-------|--------|
| DOORS | WIDTH | HEIGHT | WINDOWS | WIDTH | HEIGHT |
| D1 | 2'-0" | 7'-0" | W1 | 3'-0" | 5'-0" |
| D2 | 2'-6" | 7'-0" | W2 | 4'-0" | 4'-0" |
| D3 | 3'-0" | 7'-0" | W3 | 6'-0" | 6'-0" |
| D4 | 3'-6" | 7'-0" | W4 | 8'-0" | 8'-0" |
| D5 | 4'-0" | 7'-0" | W5 | 5'-0" | 5'-0" |
| D6 | 4'-6" | 7'-0" | W6 | | |
| D7 | 5'-0" | 7'-0" | W7 | | |
| D8 | 6'-0" | 7'-0" | V1 | 2'-0" | 2'-0" |
| D9 | 7'-0" | 7'-0" | V2 | | |

Project:
CAD MAPPING OF TEHSIL HEAD QUARTER HOSPITALS, PUNJAB


| | |
|---|--|
| Client: GOVERNMENT OF THE PUNJAB PRIMARY & SECONDARY HEALTHCARE DEPARTMENT | Consultant: SKAFS CONSULTANT (Pvt.) Limited ENGINEERING AND ENVIRONMENT CONSULTANT |
|---|--|

Drawing Title:
THQ SHABBIR SHARIF HOSPITAL MASTER PLAN PART 1

Drawing No.
SKAFS/SHABBIR SHARIF /04

MASTER PLAN OF THQ HOSPITAL SHABBIR SHARIF

PART 2

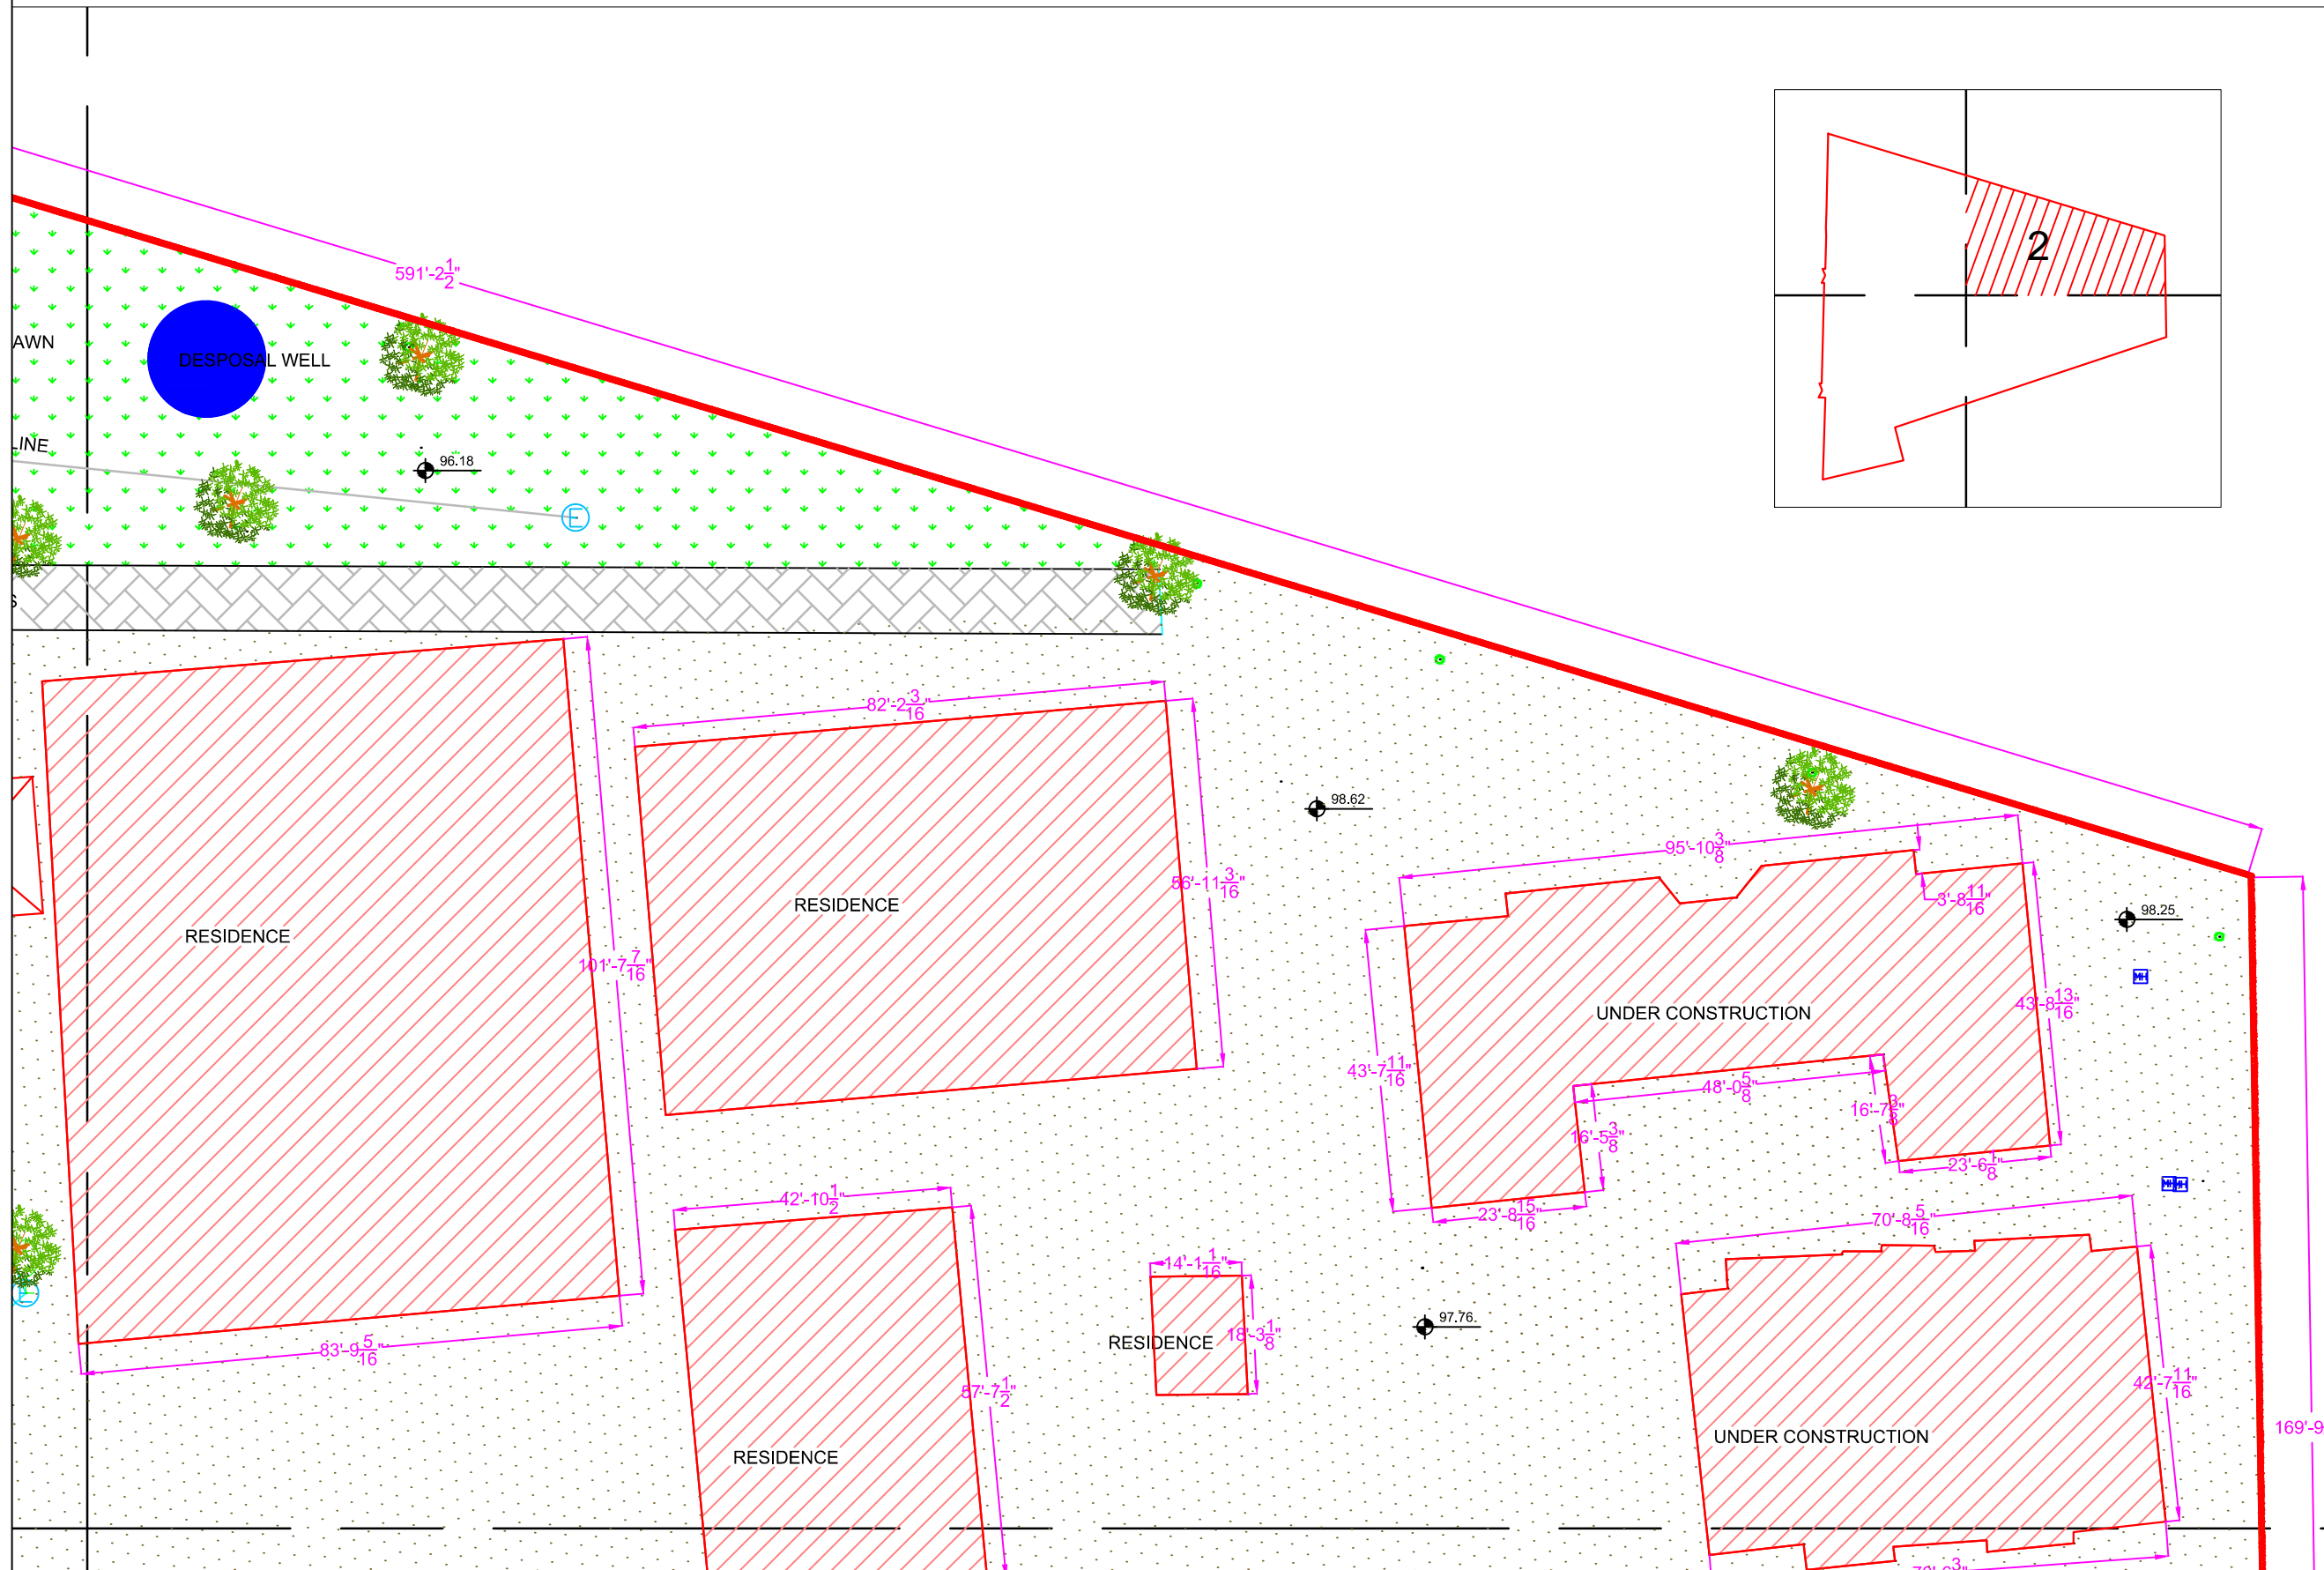

Legends:

| | |
|---------------------------|--|
| Residential Area | |
| Road | |
| Wall | |
| Power Line | |
| OHT | |
| Tree | |
| Man Hole | |
| Tube Well | |
| Light Pole | |
| Lawns | |
| Earthen Areas | |
| Asphalts Roads | |
| Tough Pavers | |
| P.C.C / Plinth Protection | |
| Boundary Wall | |
| Brick Pavers / Soling | |
| Drain | |
| Tap | |
| Hand Pump | |
| Air Conditioner | |
| Tube Light | |
| Fan | |
| Roof Light | |
| Bulb | |

| AREA | |
|---------------------------|----------------|
| AREA WITHIN BOUNDARY WALL | 210876.26 Sft |
| AREA OF CLINICAL BLOCK | 35635.8726 Sft |
| PLINTH AREA OF BLOCK | 21845.8968 Sft |

| OPENING SCHEDULE OF DOORS AND WINDOWS | | | | | |
|---------------------------------------|-------|--------|---------|-------|--------|
| DOORS | WIDTH | HEIGHT | WINDOWS | WIDTH | HEIGHT |
| D1 | 2'-0" | 7'-0" | W1 | 3'-0" | 5'-0" |
| D2 | 2'-6" | 7'-0" | W2 | 4'-0" | 4'-0" |
| D3 | 3'-0" | 7'-0" | W3 | 6'-0" | 6'-0" |
| D4 | 3'-6" | 7'-0" | W4 | 8'-0" | 8'-0" |
| D5 | 4'-0" | 7'-0" | W5 | 5'-0" | 5'-0" |
| D6 | 4'-6" | 7'-0" | W6 | | |
| D7 | 5'-0" | 7'-0" | W7 | | |
| D8 | 6'-0" | 7'-0" | V1 | 2'-0" | 2'-0" |
| D9 | 7'-0" | 7'-0" | V2 | | |

Project:
CAD MAPPING OF TEHSIL HEAD QUARTER HOSPITALS, PUNJAB


| | |
|---|--|
| Client: GOVERNMENT OF THE PUNJAB PRIMARY & SECONDARY HEALTHCARE DEPARTMENT | Consultant: SKAFS CONSULTANT (Pvt.) Limited ENGINEERING AND ENVIRONMENT CONSULTANT |
|---|--|

Drawing Title:
THQ SHABBIR SHARIF HOSPITAL MASTER PLAN PART 2


Drawing No.
SKAFS/SHABBIR SHARIF /05

MASTER PLAN OF THQ HOSPITAL SHABBIR SHARIF

PART 3

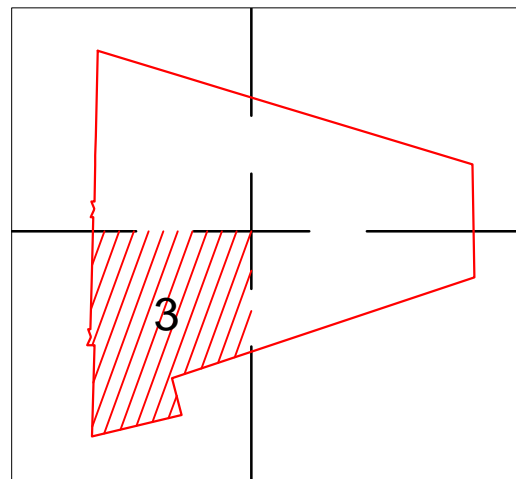

TO SARGODHA CITY

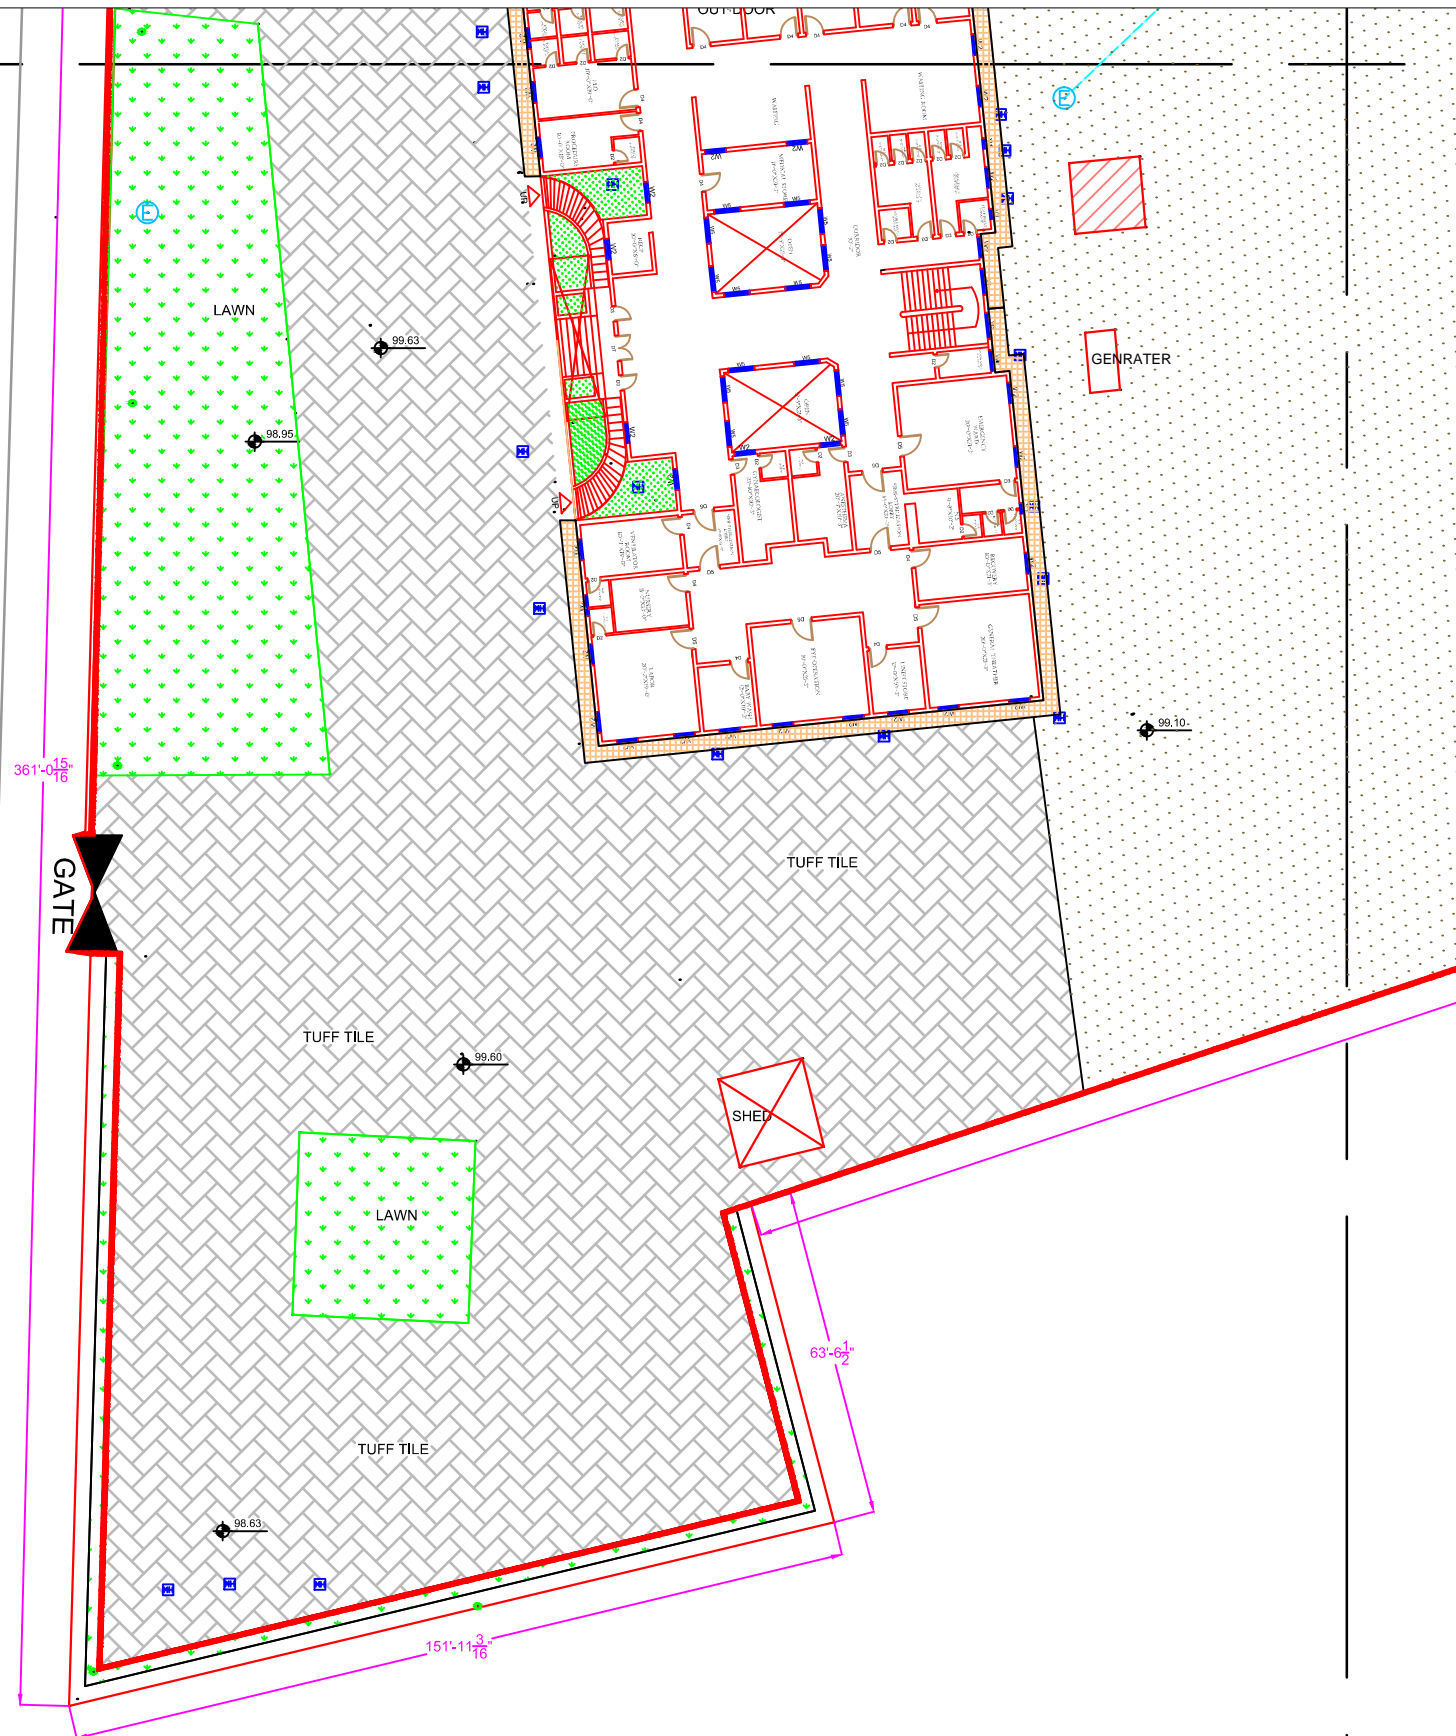

Legends:

| | |
|---------------------------|--|
| Residential Area | |
| Road | |
| Wall | |
| Power Line | |
| OHT | |
| Tree | |
| Man Hole | |
| Tube Well | |
| Light Pole | |
| Lawns | |
| Earthen Areas | |
| Asphalts Roads | |
| Tough Pavers | |
| P.C.C / Plinth Protection | |
| Boundary Wall | |
| Brick Pavers / Soling | |
| Drain | |
| Tap | |
| Hand Pump | |
| Air Conditioner | |
| Tube Light | |
| Fan | |
| Roof Light | |
| Bulb | |

| AREA | |
|---------------------------|---------------|
| AREA WITHIN BOUNDARY WALL | 210876.26 Sft |
| AREA OF CLINICAL BLOCK | 35635.8726Sft |
| PLINTH AREA OF BLOCK | 21845.8968Sft |

| OPENING SCHEDULE OF DOORS AND WINDOWS | | | | | |
|---------------------------------------|-------|--------|---------|-------|--------|
| DOORS | WIDTH | HEIGHT | WINDOWS | WIDTH | HEIGHT |
| D1 | 2'-0" | 7'-0" | W1 | 3'-0" | 5'-0" |
| D2 | 2'-6" | 7'-0" | W2 | 4'-0" | 4'-0" |
| D3 | 3'-0" | 7'-0" | W3 | 6'-0" | 6'-0" |
| D4 | 3'-6" | 7'-0" | W4 | 8'-0" | 8'-0" |
| D5 | 4'-0" | 7'-0" | W5 | 5'-0" | 5'-0" |
| D6 | 4'-6" | 7'-0" | W6 | | |
| D7 | 5'-0" | 7'-0" | W7 | | |
| D8 | 6'-0" | 7'-0" | V1 | 2'-0" | 2'-0" |
| D9 | 7'-0" | 7'-0" | V2 | | |

Project:
CAD MAPPING OF TEHSIL HEAD QUARTER HOSPITALS, PUNJAB


| | |
|---|--|
| Client: GOVERNMENT OF THE PUNJAB PRIMARY & SECONDARY HEALTHCARE DEPARTMENT | Consultant: SKAFS CONSULTANT (Pvt.) Limited ENGINEERING AND ENVIRONMENT CONSULTANT |
|---|--|

Drawing Title:
THQ SHABBIR SHARIF HOSPITAL MASTER PLAN PART 3

Drawing No.
SKAFS/SHABBIR SHARIF /06

MASTER PLAN OF THQ HOSPITAL SHABBIR SHARIF

PART 4

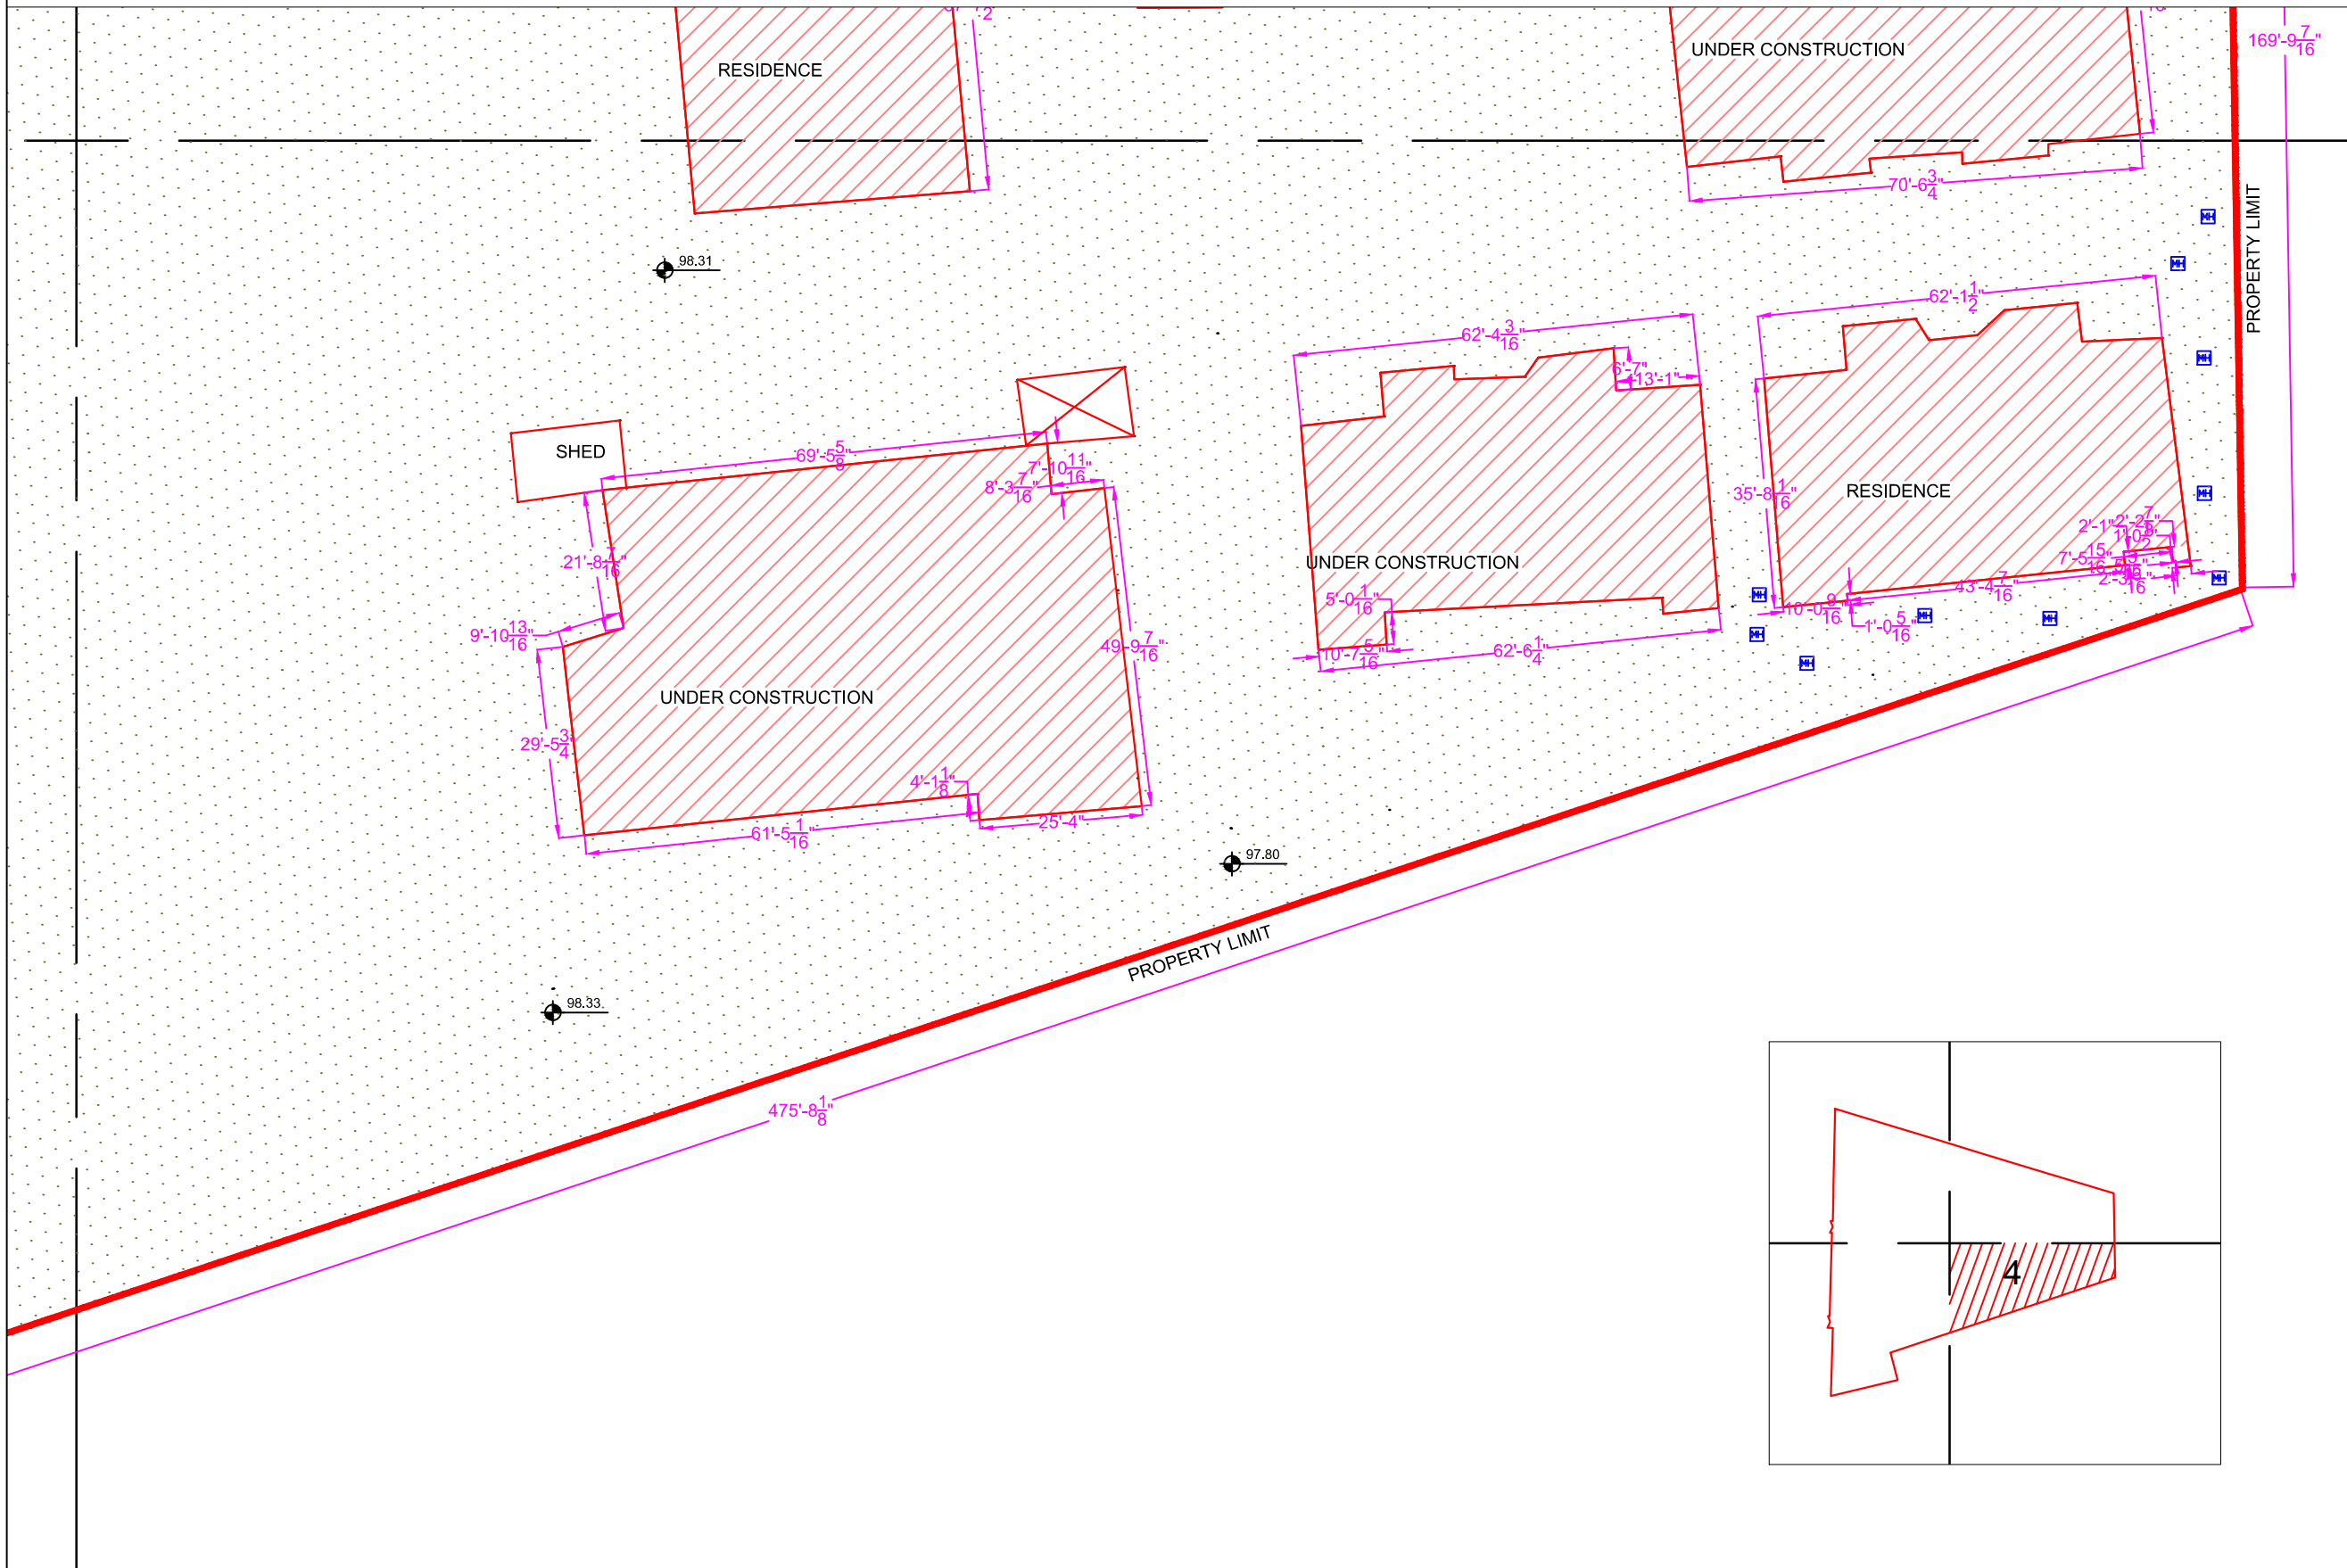


Legends:

| | |
|---------------------------|--|
| Residential Area | |
| Road | |
| Wall | |
| Power Line | |
| OHT | |
| Tree | |
| Man Hole | |
| Tube Well | |
| Light Pole | |
| Lawns | |
| Earthen Areas | |
| Asphalts Roads | |
| Tough Pavers | |
| P.C.C / Plinth Protection | |
| Boundary Wall | |
| Brick Pavers / Soling | |
| Drain | |
| Tap | |
| Hand Pump | |
| Air Conditioner | |
| Tube Light | |
| Fan | |
| Roof Light | |
| Bulb | |

| AREA | |
|---------------------------|---------------|
| AREA WITHIN BOUNDARY WALL | 210876.26 Sft |
| AREA OF CLINICAL BLOCK | 35635.8726Sft |
| PLINTH AREA OF BLOCK | 21845.8968Sft |

| OPENING SCHEDULE OF DOORS AND WINDOWS | | | | | |
|---------------------------------------|-------|--------|---------|-------|--------|
| DOORS | WIDTH | HEIGHT | WINDOWS | WIDTH | HEIGHT |
| D1 | 2'-0" | 7'-0" | W1 | 3'-0" | 5'-0" |
| D2 | 2'-6" | 7'-0" | W2 | 4'-0" | 4'-0" |
| D3 | 3'-0" | 7'-0" | W3 | 6'-0" | 6'-0" |
| D4 | 3'-6" | 7'-0" | W4 | 8'-0" | 8'-0" |
| D5 | 4'-0" | 7'-0" | W5 | 5'-0" | 5'-0" |
| D6 | 4'-6" | 7'-0" | W6 | | |
| D7 | 5'-0" | 7'-0" | W7 | | |
| D8 | 6'-0" | 7'-0" | V1 | 2'-0" | 2'-0" |
| D9 | 7'-0" | 7'-0" | V2 | | |

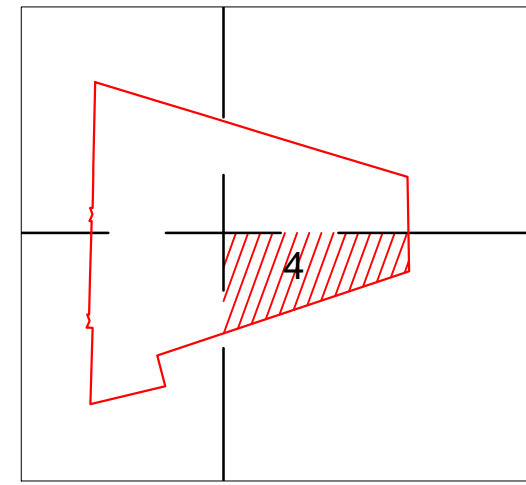

Project:
CAD MAPPING OF TEHSIL HEAD QUARTER HOSPITALS, PUNJAB

| | |
|---|--|
| Client: GOVERNMENT OF THE PUNJAB PRIMARY & SECONDARY HEALTHCARE DEPARTMENT | Consultant: SKAFS CONSULTANT (Pvt.) Limited ENGINEERING AND ENVIRONMENT CONSULTANT |
|---|--|

Drawing Title:
THQ SHABBIR SHARIF HOSPITAL MASTER PLAN PART 4

Drawing No.
SKAFS/SHABBIR SHARIF /07

CLINICAL BLOCK OF THQ HOSPITAL SHABBIR SHARIF GROUND FLOOR


PART 1

PART 2

PART 3

PART 4

GROUND FLOOR PLAN

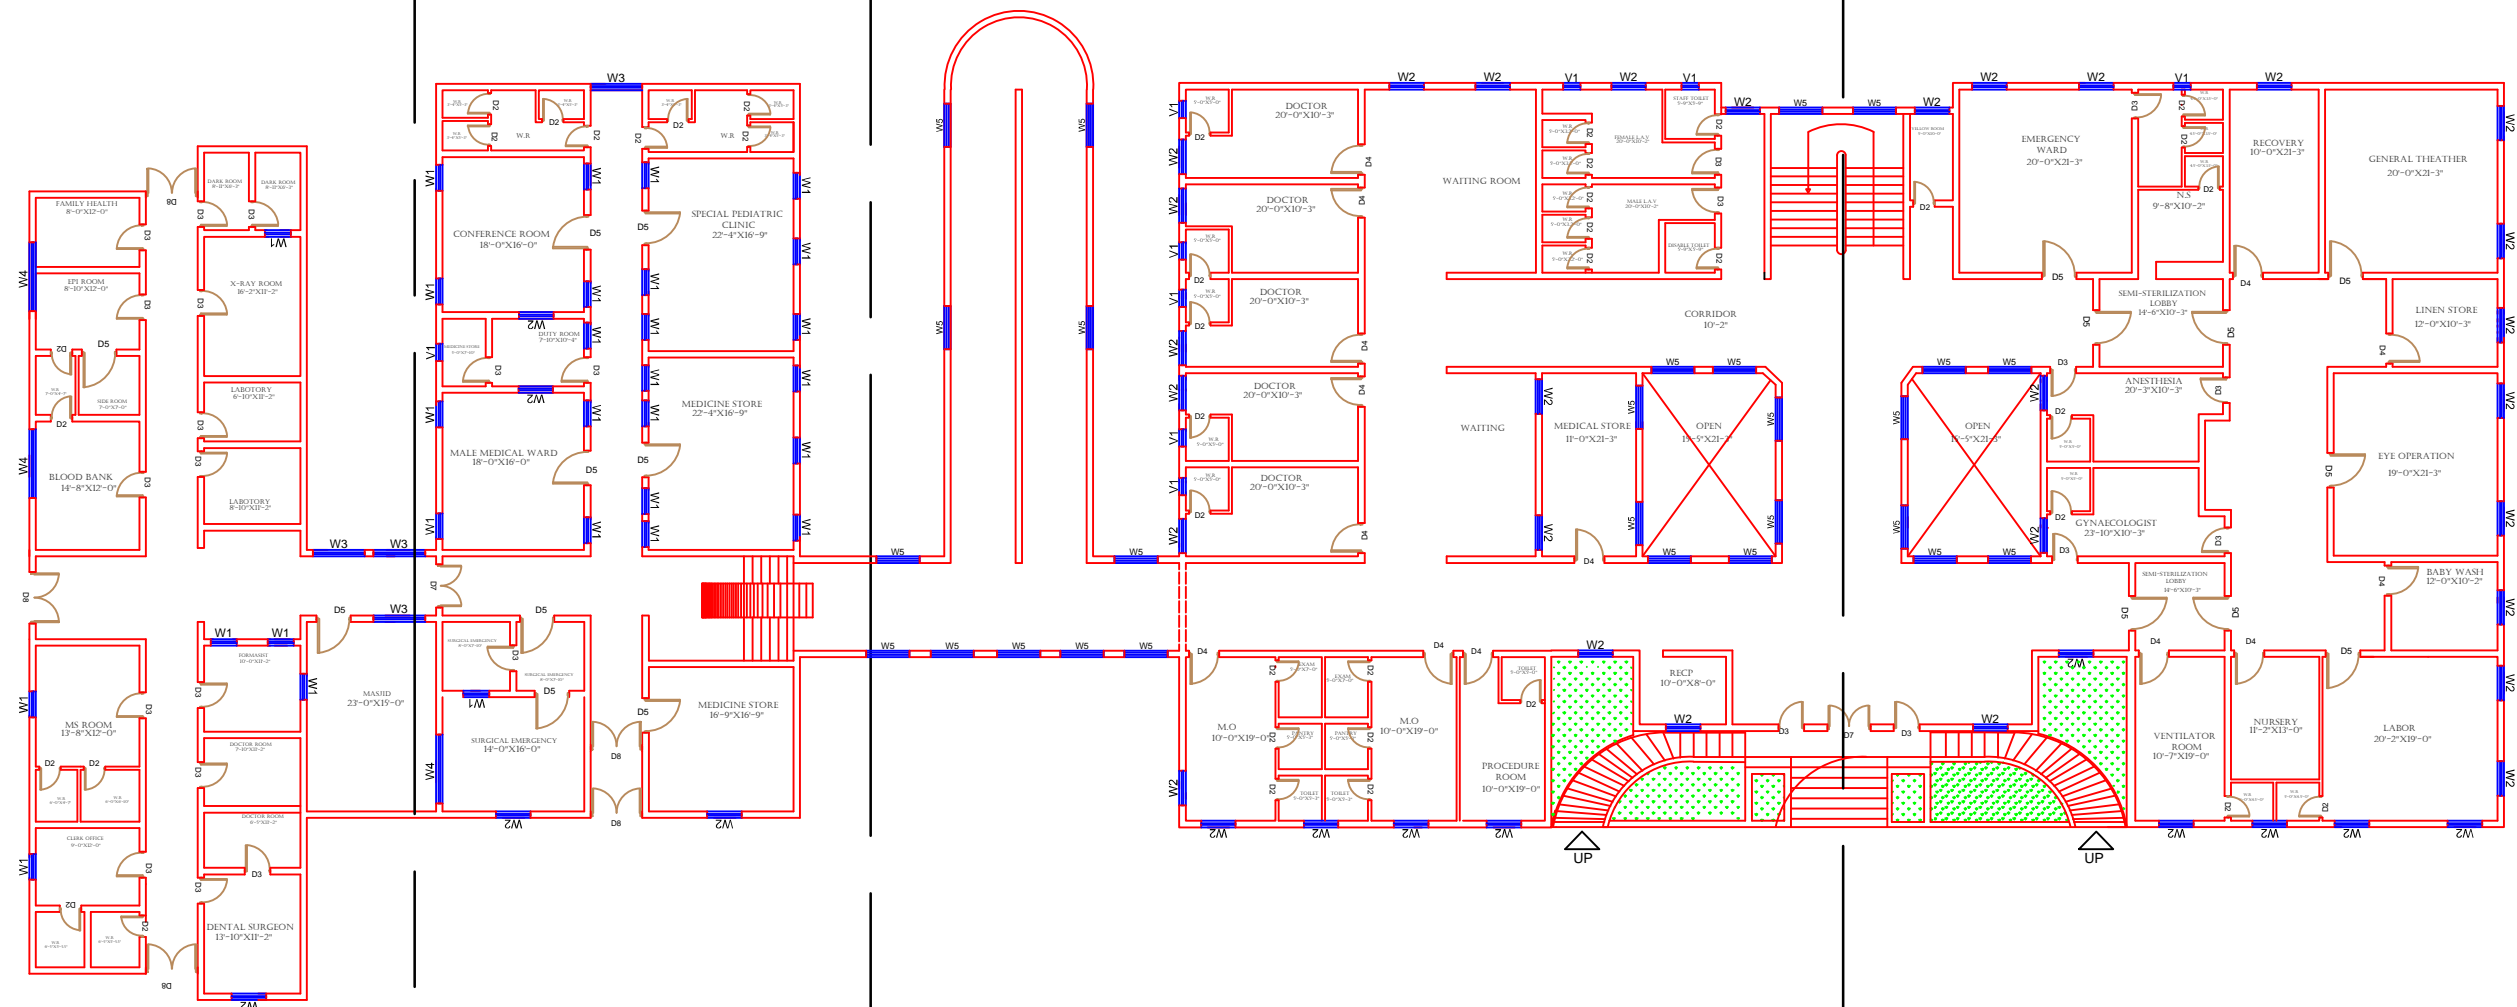

Legends:

| | |
|---------------------------|--|
| Residential Area | |
| Road | |
| Wall | |
| Power Line | |
| OHT | |
| Tree | |
| Man Hole | |
| Tube Well | |
| Light Pole | |
| Lawns | |
| Earthen Areas | |
| Asphalts Roads | |
| Tough Pavers | |
| P.C.C / Plinth Protection | |
| Boundary Wall | |
| Brick Pavers / Soling | |
| Drain | |
| Tap | |
| Hand Pump | |
| Air Conditioner | |
| Tube Light | |
| Fan | |
| Roof Light | |
| Bulb | |

| AREA | |
|---------------------------|---------------|
| AREA WITHIN BOUNDARY WALL | 210876.26 Sft |
| AREA OF CLINICAL BLOCK | 35635.8726Sft |
| PLINTH AREA OF BLOCK | 21845.8968Sft |

| OPENING SCHEDULE OF DOORS AND WINDOWS | | | | | |
|---------------------------------------|-------|--------|---------|-------|--------|
| DOORS | WIDTH | HEIGHT | WINDOWS | WIDTH | HEIGHT |
| D1 | 2'-0" | 7'-0" | W1 | 3'-0" | 5'-0" |
| D2 | 2'-6" | 7'-0" | W2 | 4'-0" | 4'-0" |
| D3 | 3'-0" | 7'-0" | W3 | 6'-0" | 6'-0" |
| D4 | 3'-6" | 7'-0" | W4 | 8'-0" | 8'-0" |
| D5 | 4'-0" | 7'-0" | W5 | 5'-0" | 5'-0" |
| D6 | 4'-6" | 7'-0" | W6 | | |
| D7 | 5'-0" | 7'-0" | W7 | | |
| D8 | 6'-0" | 7'-0" | V1 | 2'-0" | 2'-0" |
| D9 | 7'-0" | 7'-0" | V2 | | |

Project:
**CAD MAPPING OF TEHSIL
HEAD QUARTER HOSPITALS,
PUNJAB**


| | |
|---|--|
| Client: GOVERNMENT OF THE PUNJAB PRIMARY & SECONDARY HEALTHCARE DEPARTMENT | Consultant: SKAFS CONSULTANT (Pvt.) Limited ENGINEERING AND ENVIRONMENT CONSULTANT |
|---|--|

Drawing Title:
**THQ SHABBIR SHARIF
HOSPITAL CLINICAL BLOCK PLAN**

Drawing No.
SKAFS/SHABBIR SHARIF /08

CLINICAL BLOCK OF THQ HOSPITAL SHABBIR SHARIF

GROUND FLOOR PART 1

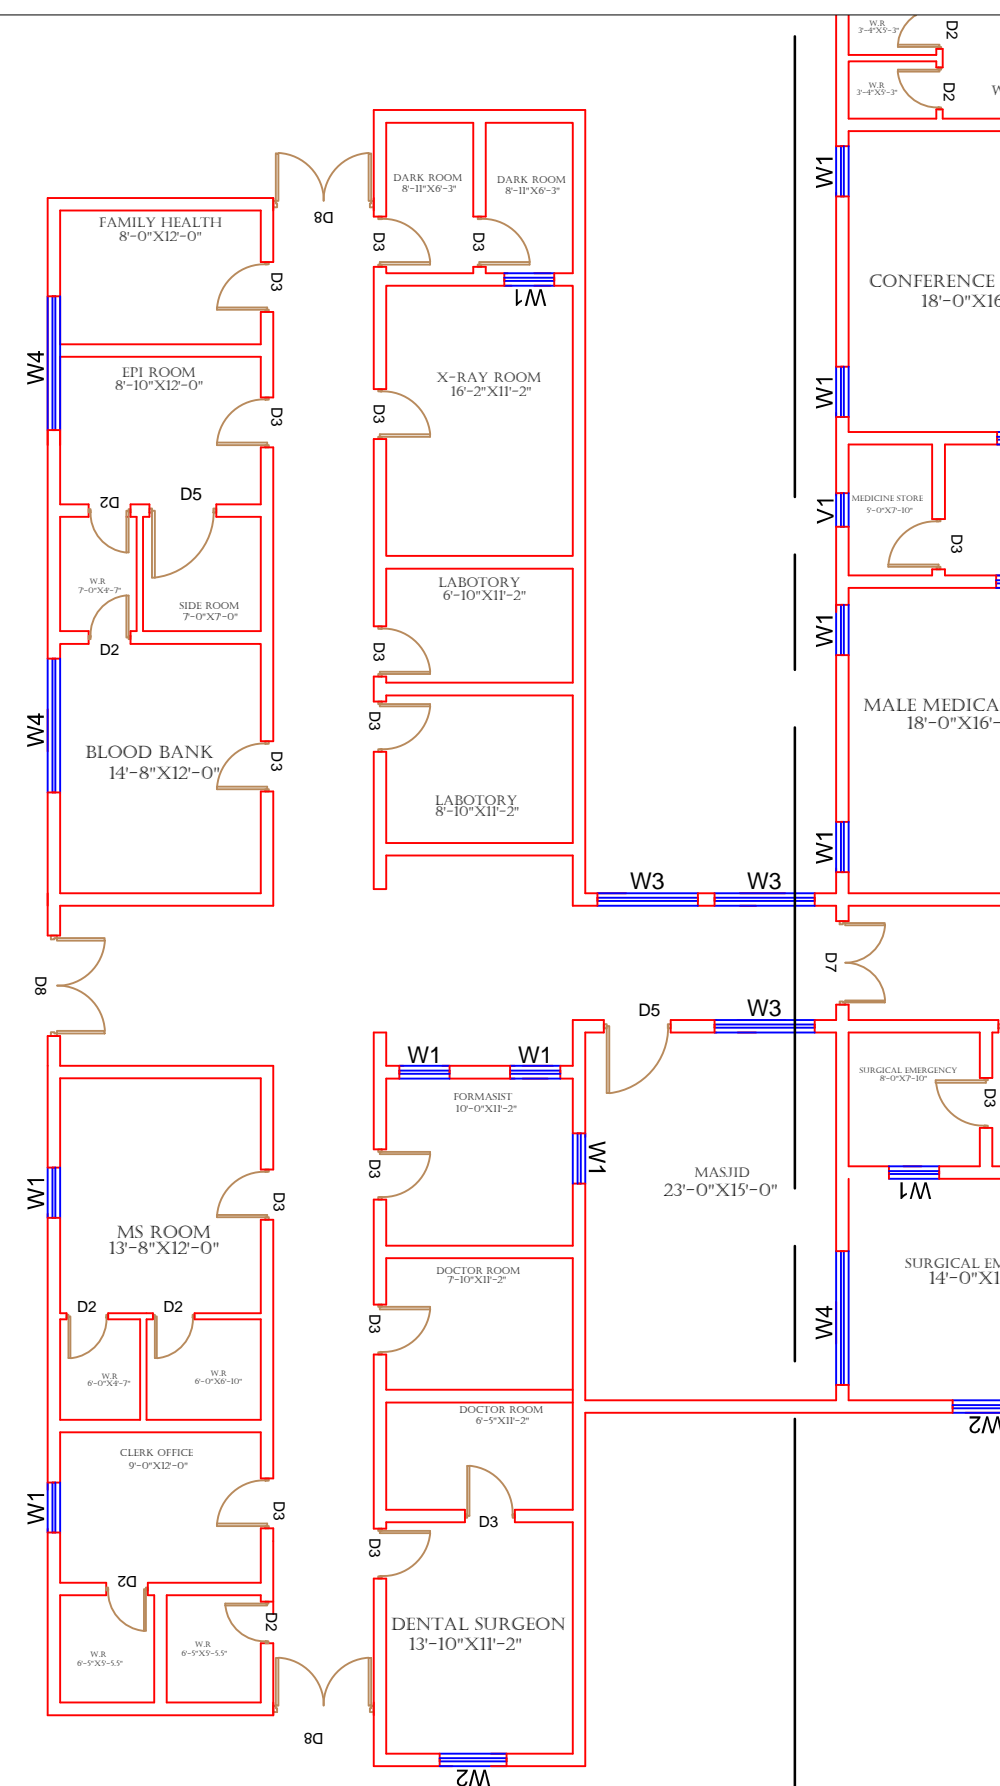

Legends:

| | |
|---------------------------|--|
| Residential Area | |
| Road | |
| Wall | |
| Power Line | |
| OHT | |
| Tree | |
| Man Hole | |
| Tube Well | |
| Light Pole | |
| Lawns | |
| Earthen Areas | |
| Asphalts Roads | |
| Tough Pavers | |
| P.C.C / Plinth Protection | |
| Boundary Wall | |
| Brick Pavers / Soling | |
| Drain | |
| Tap | |
| Hand Pump | |
| Air Conditioner | |
| Tube Light | |
| Fan | |
| Roof Light | |
| Bulb | |

| AREA | |
|---------------------------|---------------|
| AREA WITHIN BOUNDARY WALL | 210876.26 Sft |
| AREA OF CLINICAL BLOCK | 35635.8726Sft |
| PLINTH AREA OF BLOCK | 21845.8968Sft |

| OPENING SCHEDULE OF DOORS AND WINDOWS | | | | | |
|---------------------------------------|-------|--------|---------|-------|--------|
| DOORS | WIDTH | HEIGHT | WINDOWS | WIDTH | HEIGHT |
| D1 | 2'-0" | 7'-0" | W1 | 3'-0" | 5'-0" |
| D2 | 2'-6" | 7'-0" | W2 | 4'-0" | 4'-0" |
| D3 | 3'-0" | 7'-0" | W3 | 6'-0" | 6'-0" |
| D4 | 3'-6" | 7'-0" | W4 | 8'-0" | 8'-0" |
| D5 | 4'-0" | 7'-0" | W5 | 5'-0" | 5'-0" |
| D6 | 4'-6" | 7'-0" | W6 | | |
| D7 | 5'-0" | 7'-0" | W7 | | |
| D8 | 6'-0" | 7'-0" | V1 | 2'-0" | 2'-0" |
| D9 | 7'-0" | 7'-0" | V2 | | |

Project:
CAD MAPPING OF TEHSIL HEAD QUARTER HOSPITALS, PUNJAB


| | |
|---|--|
| Client: GOVERNMENT OF THE PUNJAB PRIMARY & SECONDARY HEALTHCARE DEPARTMENT | Consultant: SKAFS CONSULTANT (Pvt.) Limited ENGINEERING AND ENVIRONMENT CONSULTANT |
|---|--|

Drawing Title:
THQ SHABBIR SHARIF CLINICAL BLOCK PLAN (PART 1)

Drawing No.
SKAFS/SHABBIR SHARIF /09

CLINICAL BLOCK OF THQ HOSPITAL SHABBIR SHARIF

GROUND FLOOR PART 2

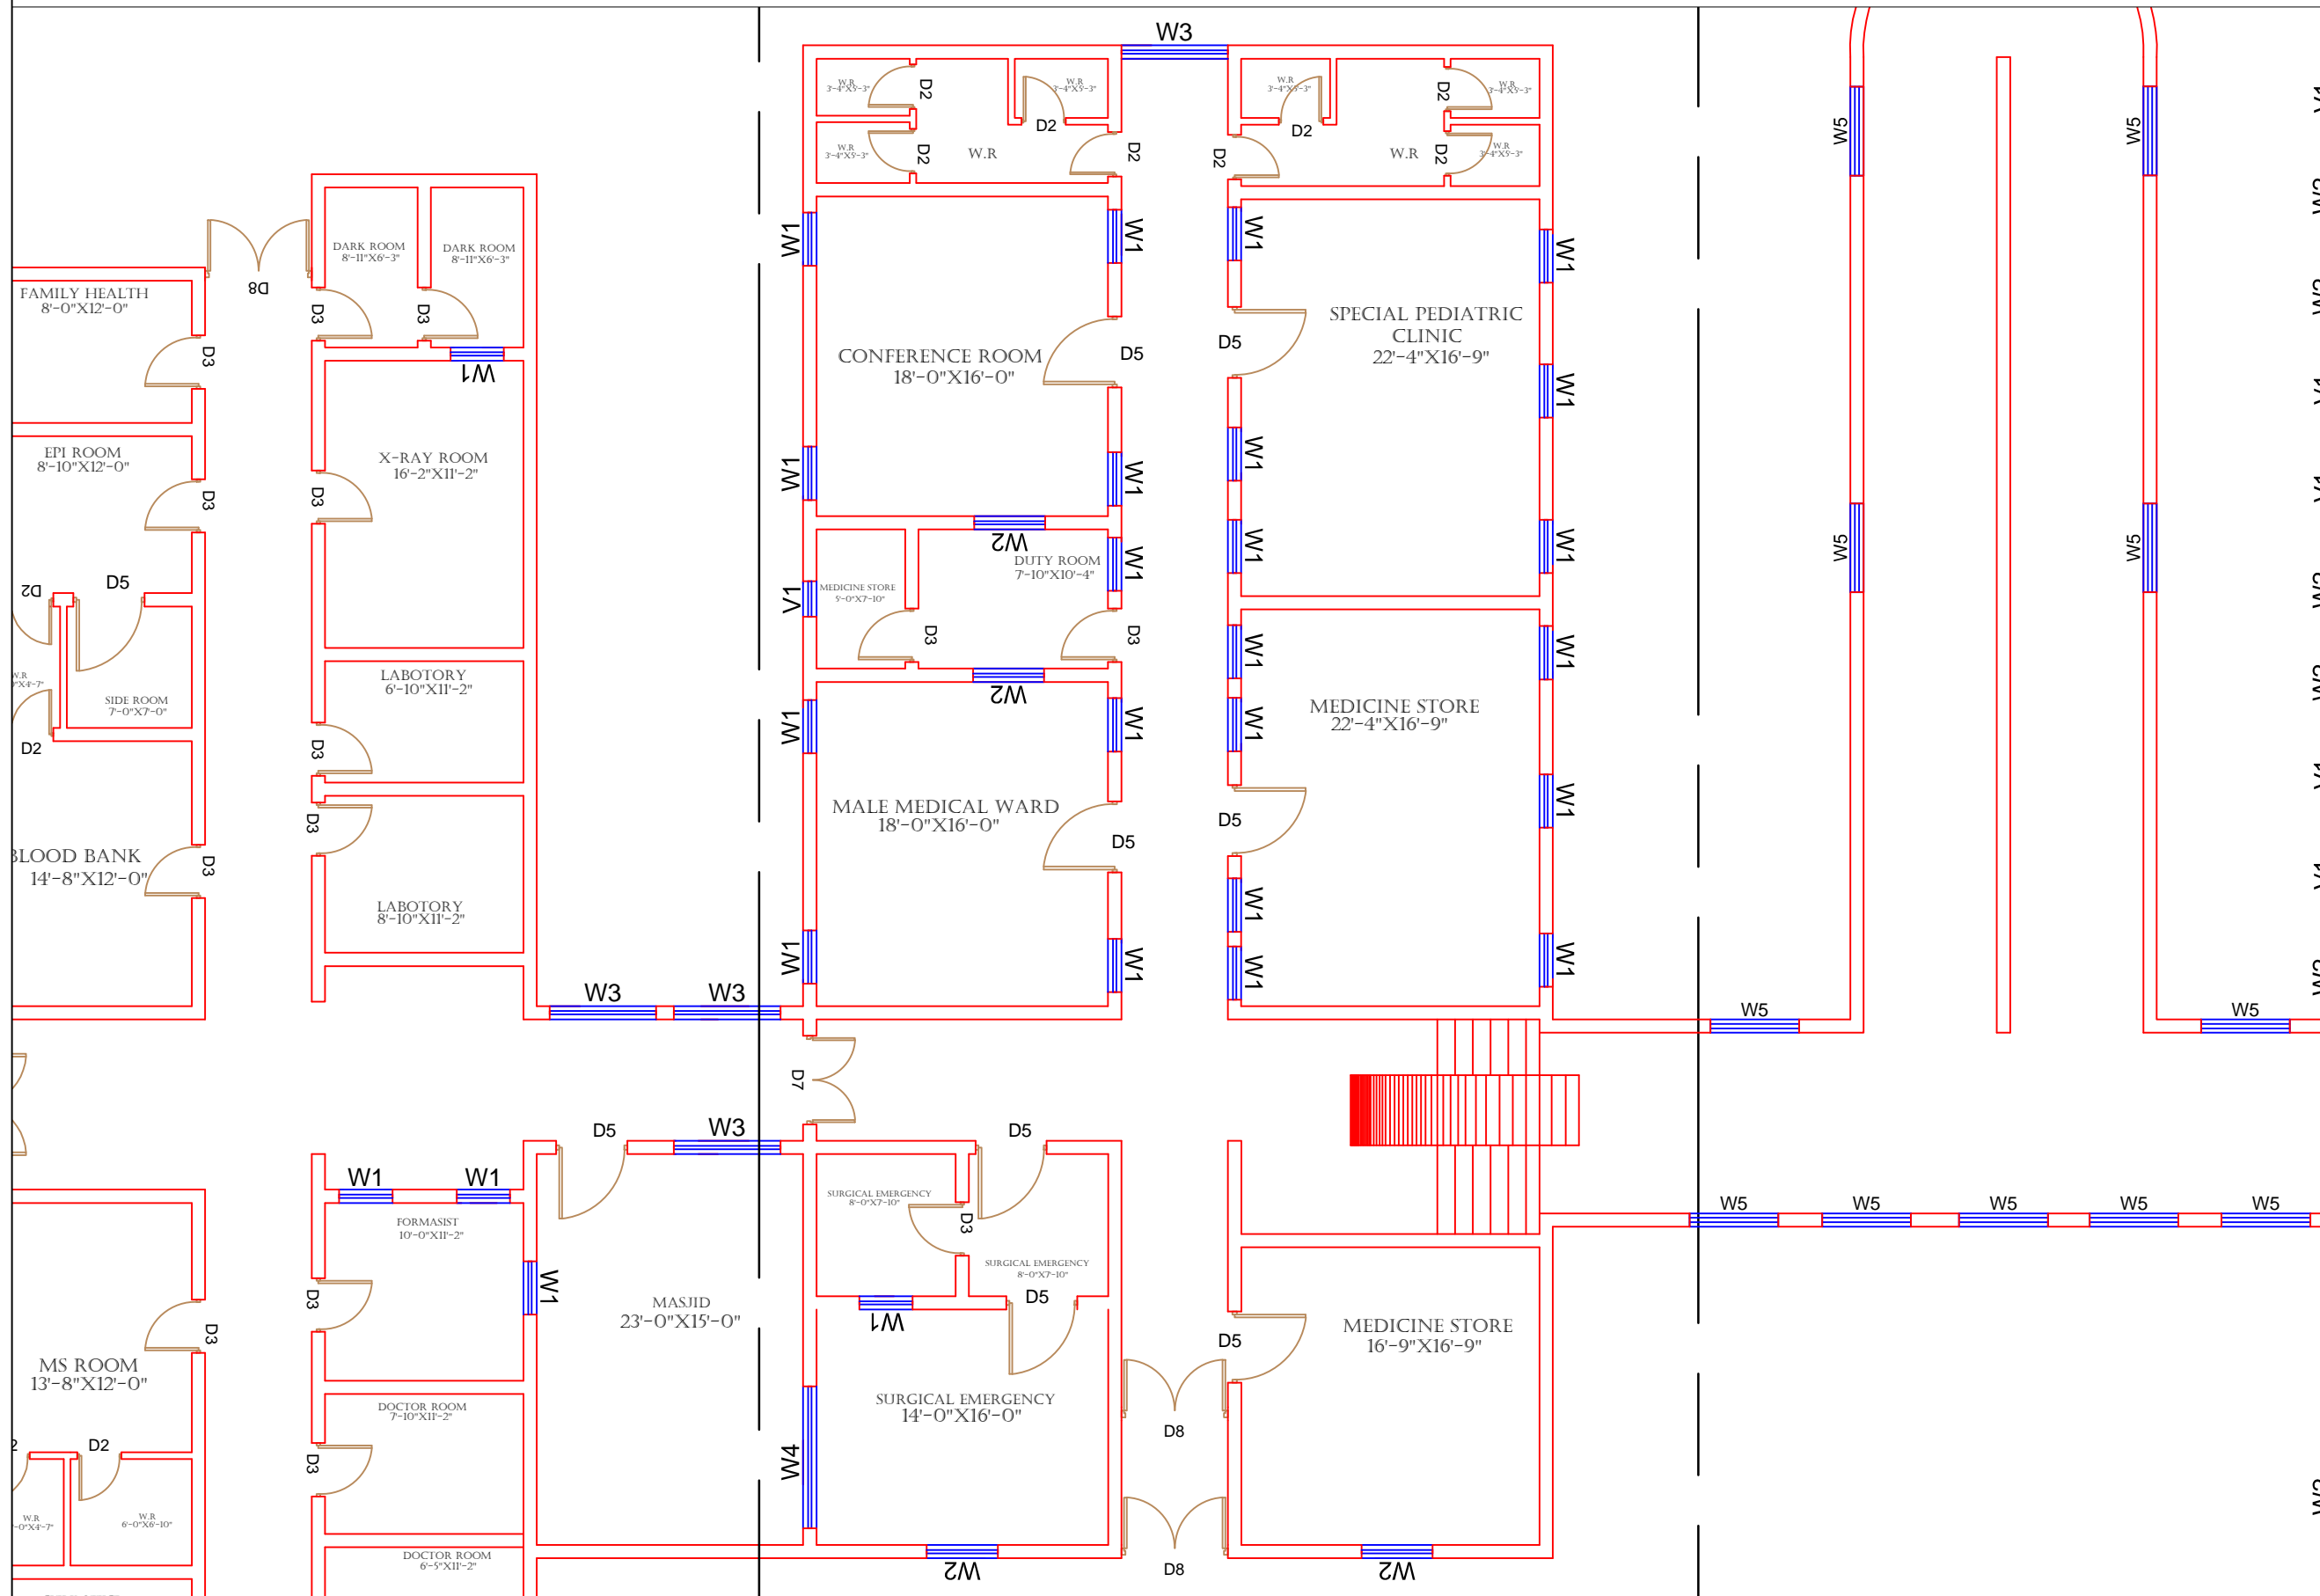

Legends:

| | |
|---------------------------|--|
| Residential Area | |
| Road | |
| Wall | |
| Power Line | |
| OHT | |
| Tree | |
| Man Hole | |
| Tube Well | |
| Light Pole | |
| Lawns | |
| Earthen Areas | |
| Asphalts Roads | |
| Tough Pavers | |
| P.C.C / Plinth Protection | |
| Boundary Wall | |
| Brick Pavers / Soling | |
| Drain | |
| Tap | |
| Hand Pump | |
| Air Conditioner | |
| Tube Light | |
| Fan | |
| Roof Light | |
| Bulb | |

| AREA | |
|---------------------------|---------------|
| AREA WITHIN BOUNDARY WALL | 210876.26 Sft |
| AREA OF CLINICAL BLOCK | 35635.8726Sft |
| PLINTH AREA OF BLOCK | 21845.8968Sft |

| OPENING SCHEDULE OF DOORS AND WINDOWS | | | | | |
|---------------------------------------|-------|--------|---------|-------|--------|
| DOORS | WIDTH | HEIGHT | WINDOWS | WIDTH | HEIGHT |
| D1 | 2'-0" | 7'-0" | W1 | 3'-0" | 5'-0" |
| D2 | 2'-6" | 7'-0" | W2 | 4'-0" | 4'-0" |
| D3 | 3'-0" | 7'-0" | W3 | 6'-0" | 6'-0" |
| D4 | 3'-6" | 7'-0" | W4 | 8'-0" | 8'-0" |
| D5 | 4'-0" | 7'-0" | W5 | 5'-0" | 5'-0" |
| D6 | 4'-6" | 7'-0" | W6 | | |
| D7 | 5'-0" | 7'-0" | W7 | | |
| D8 | 6'-0" | 7'-0" | V1 | 2'-0" | 2'-0" |
| D9 | 7'-0" | 7'-0" | V2 | | |

Project:
CAD MAPPING OF TEHSIL HEAD QUARTER HOSPITALS, PUNJAB


| | |
|---|--|
| Client: GOVERNMENT OF THE PUNJAB PRIMARY & SECONDARY HEALTHCARE DEPARTMENT | Consultant: SKAFS CONSULTANT (Pvt.) Limited ENGINEERING AND ENVIRONMENT CONSULTANT |
|---|--|

Drawing Title:
THQ SHABBIR SHARIF CLINICAL BLOCK PLAN (PART 2)

Drawing No. **SKAFS/SHABBIR SHARIF /10**

CLINICAL BLOCK OF THQ HOSPITAL SHABBIR SHARIF

GROUND FLOOR PART 3

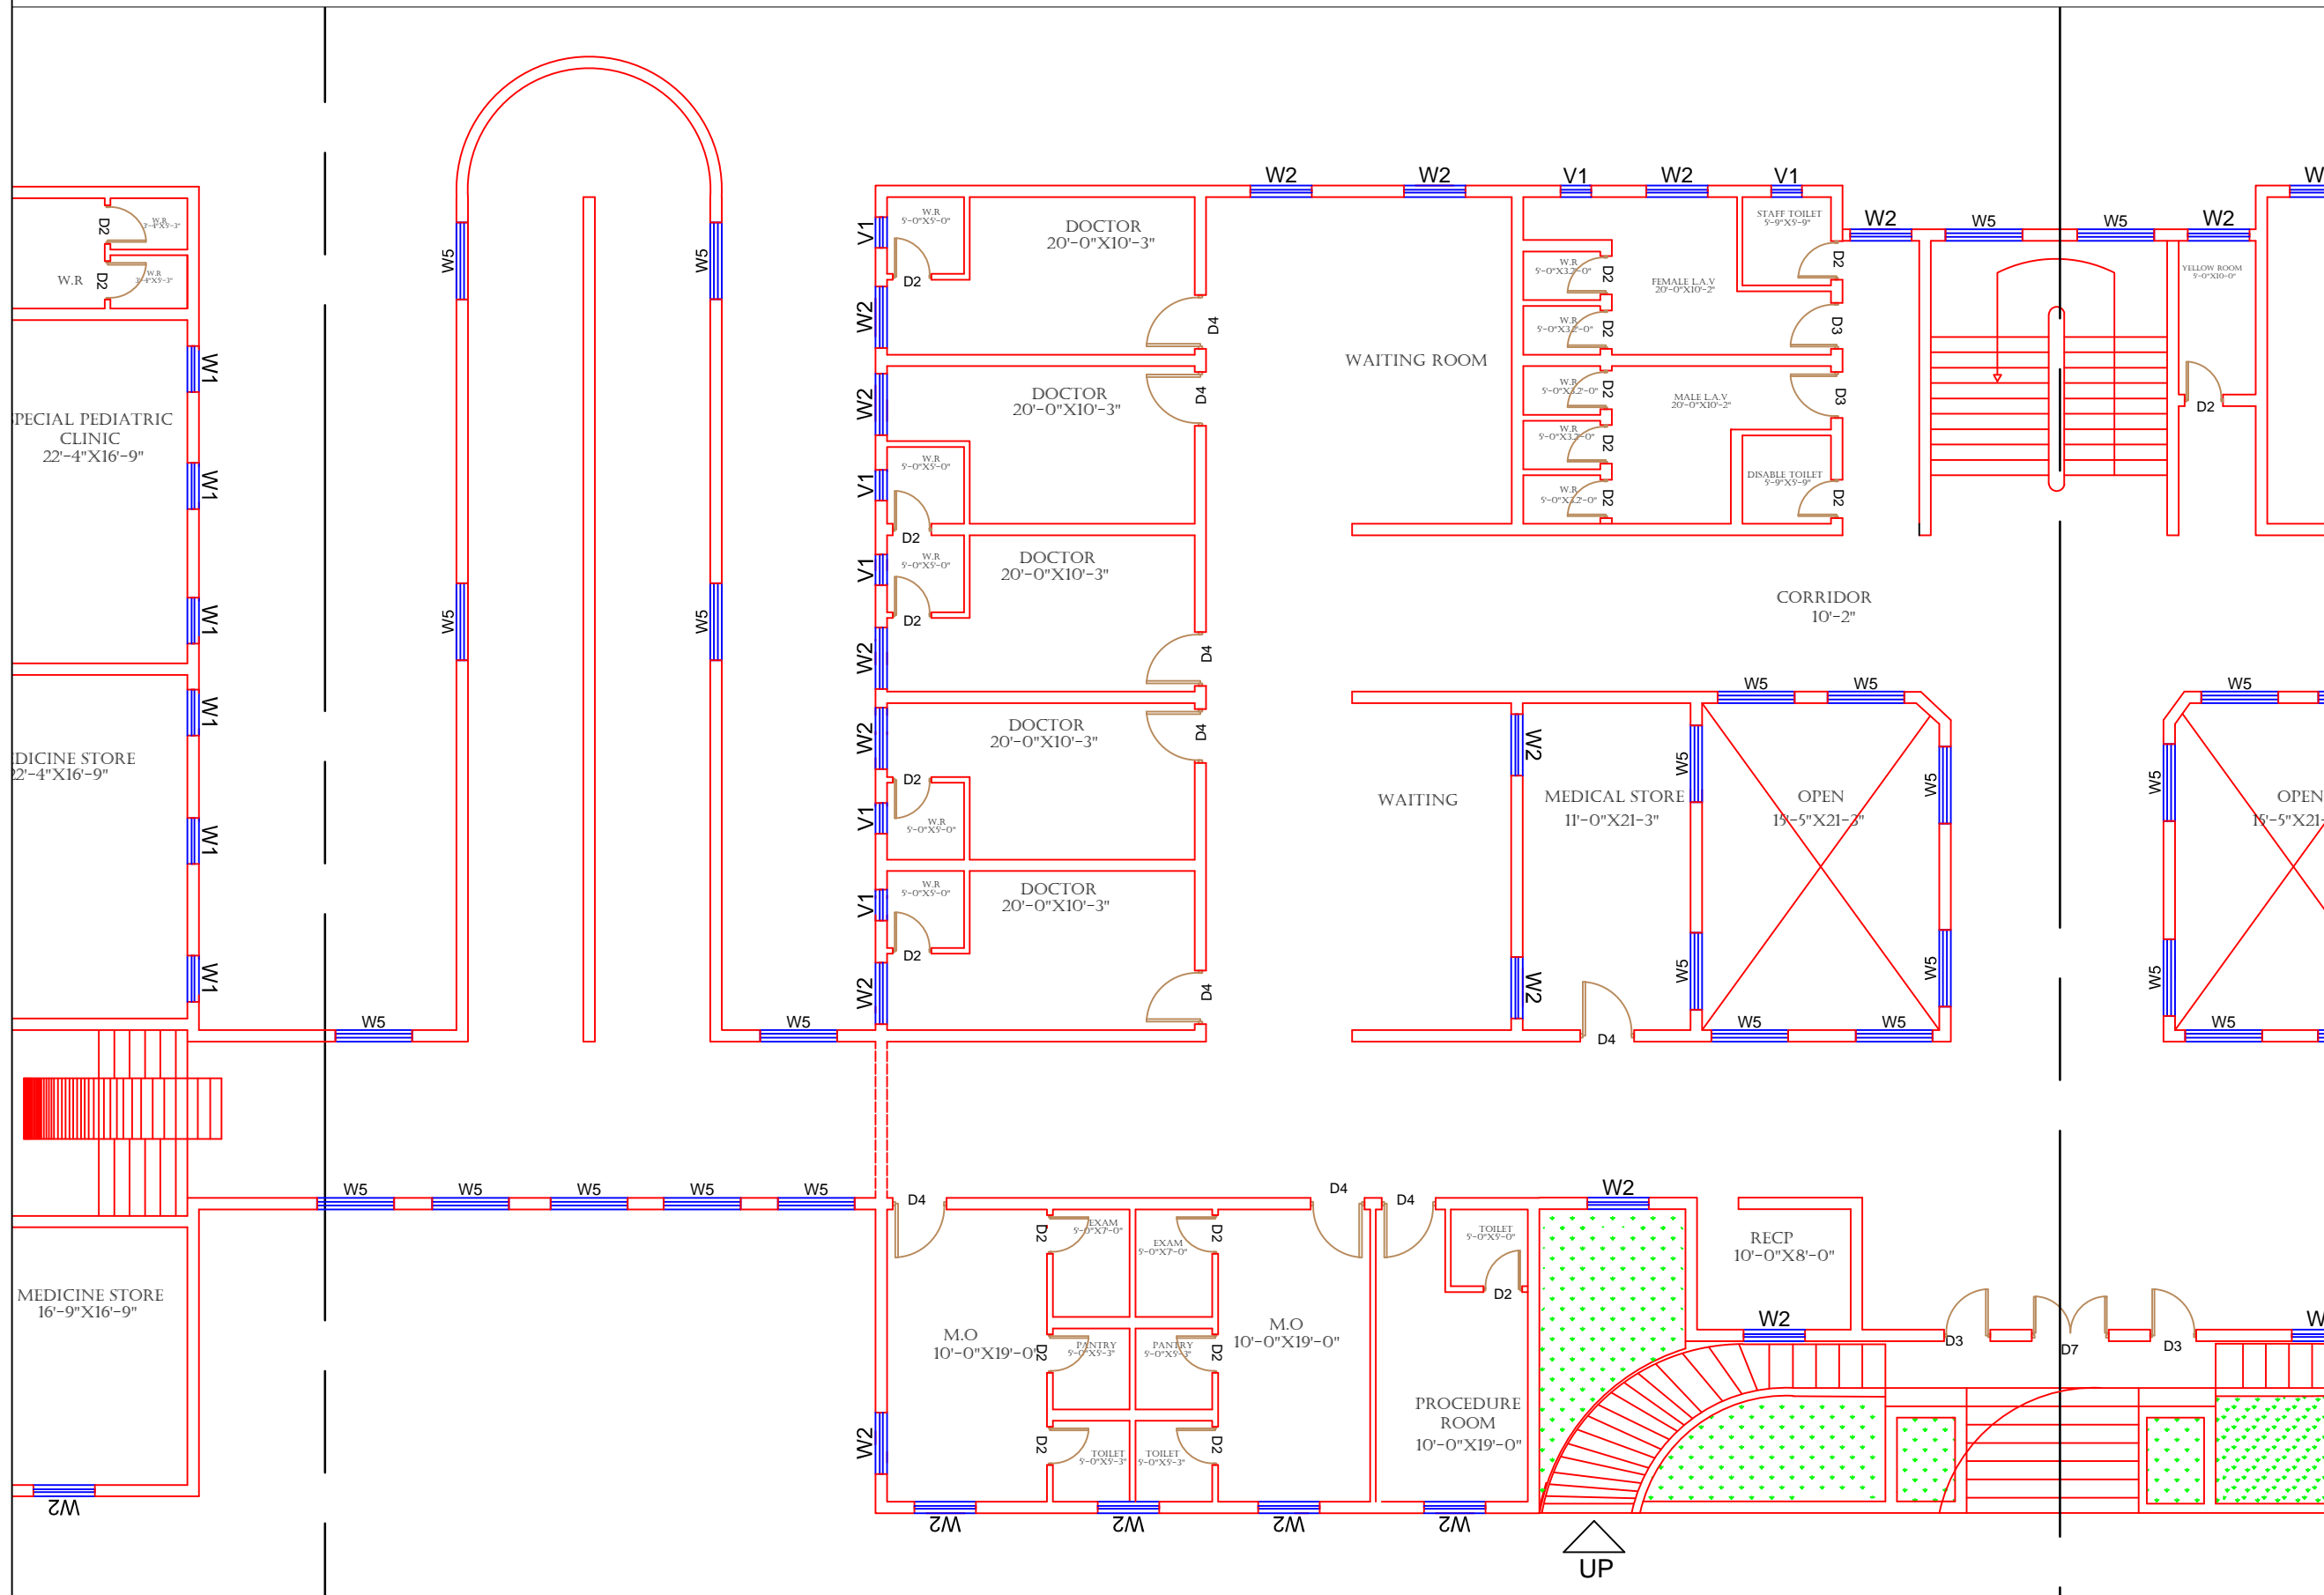

Legends:

| | |
|---------------------------|--|
| Residential Area | |
| Road | |
| Wall | |
| Power Line | |
| OHT | |
| Tree | |
| Man Hole | |
| Tube Well | |
| Light Pole | |
| Lawns | |
| Earthen Areas | |
| Asphalts Roads | |
| Tough Pavers | |
| P.C.C / Plinth Protection | |
| Boundary Wall | |
| Brick Pavers / Soling | |
| Drain | |
| Tap | |
| Hand Pump | |
| Air Conditioner | |
| Tube Light | |
| Fan | |
| Roof Light | |
| Bulb | |

AREA

| | |
|---------------------------|----------------|
| AREA WITHIN BOUNDARY WALL | 210876.26 Sft |
| AREA OF CLINICAL BLOCK | 35635.8726 Sft |
| PLINTH AREA OF BLOCK | 21845.8968 Sft |

OPENING SCHEDULE OF DOORS AND WINDOWS

| DOORS | WIDTH | HEIGHT | WINDOWS | WIDTH | HEIGHT |
|-------|-------|--------|---------|-------|--------|
| D1 | 2'-0" | 7'-0" | W1 | 3'-0" | 5'-0" |
| D2 | 2'-6" | 7'-0" | W2 | 4'-0" | 4'-0" |
| D3 | 3'-0" | 7'-0" | W3 | 6'-0" | 6'-0" |
| D4 | 3'-6" | 7'-0" | W4 | 8'-0" | 8'-0" |
| D5 | 4'-0" | 7'-0" | W5 | 5'-0" | 5'-0" |
| D6 | 4'-6" | 7'-0" | W6 | | |
| D7 | 5'-0" | 7'-0" | W7 | | |
| D8 | 6'-0" | 7'-0" | V1 | 2'-0" | 2'-0" |
| D9 | 7'-0" | 7'-0" | V2 | | |

Project:
CAD MAPPING OF TEHSIL HEAD QUARTER HOSPITALS, PUNJAB

Client: GOVERNMENT OF THE PUNJAB
PRIMARY & SECONDARY HEALTHCARE DEPARTMENT


Consultant: SKAFS CONSULTANT (Pvt.) Limited
ENGINEERING AND ENVIRONMENT CONSULTANT

Drawing Title:
THQ SHABBIR SHARIF CLINICAL BLOCK PLAN (PART 3)

Drawing No. **SKAFS/SHABBIR SHARIF /11**

CLINICAL BLOCK OF THQ HOSPITAL SHABBIR SHARIF

GROUND FLOOR PART 4

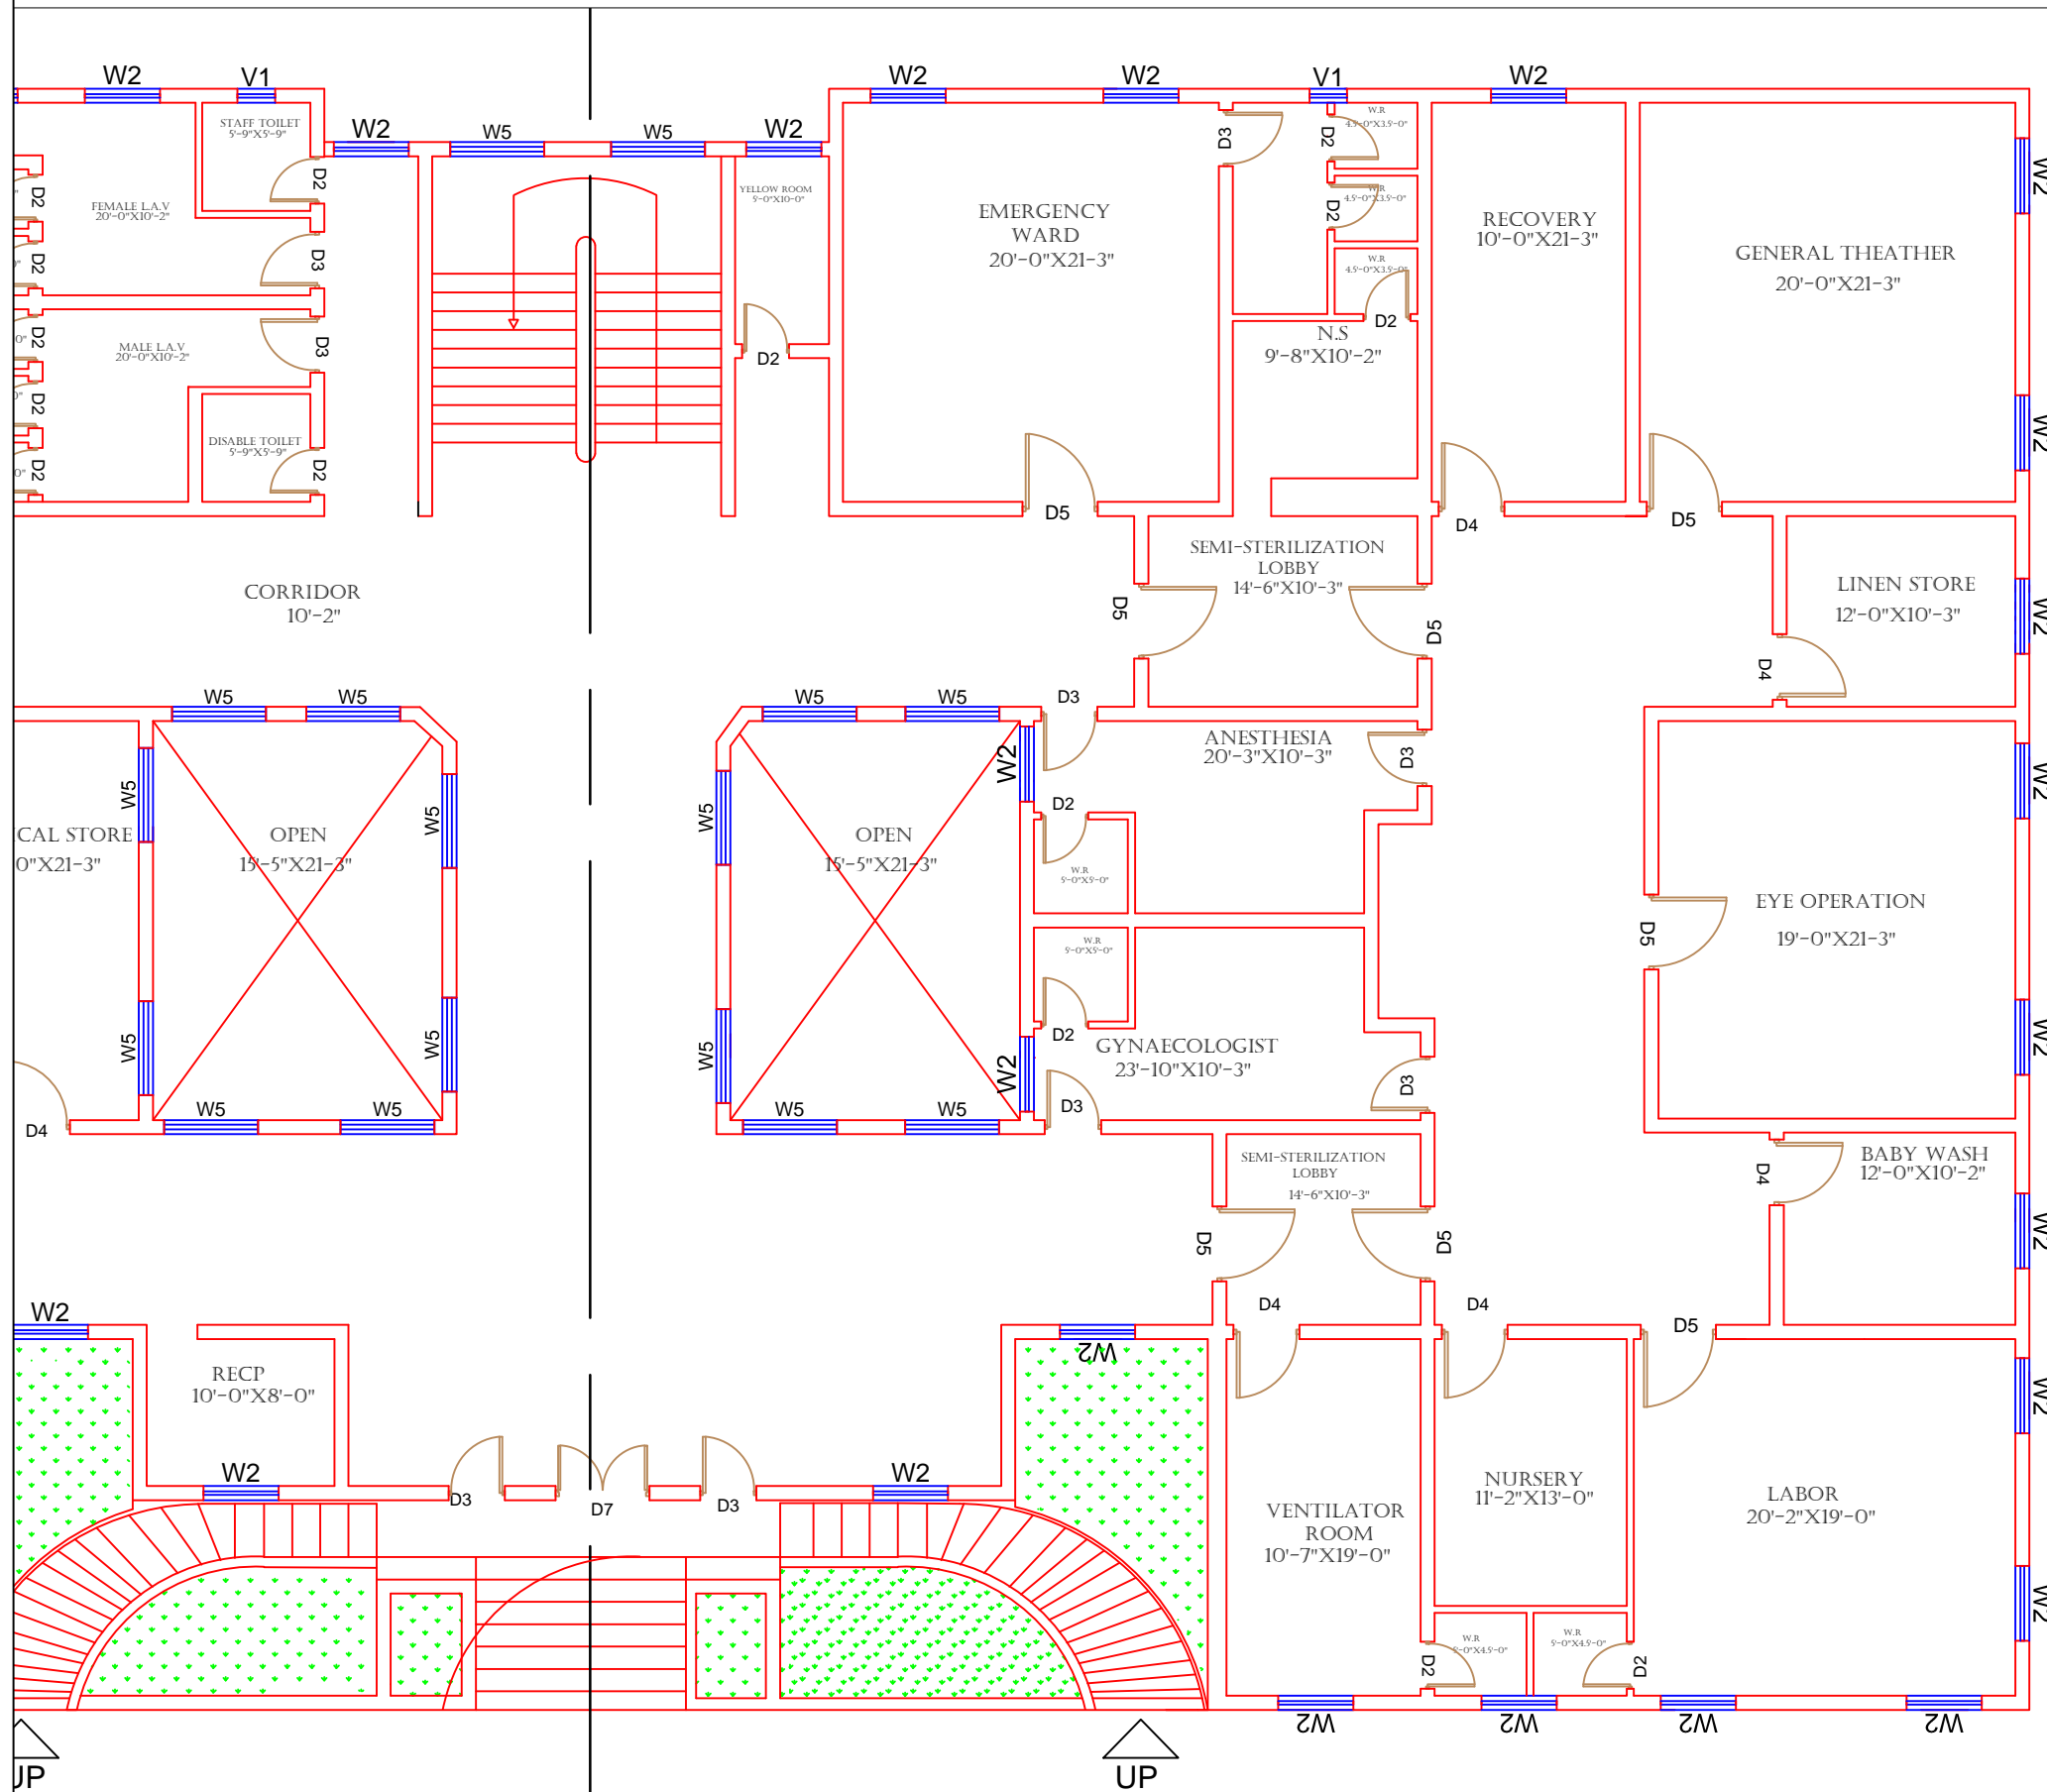

Legends:

| | |
|---------------------------|--|
| Residential Area | |
| Road | |
| Wall | |
| Power Line | |
| OHT | |
| Tree | |
| Man Hole | |
| Tube Well | |
| Light Pole | |
| Lawns | |
| Earthen Areas | |
| Asphalts Roads | |
| Tough Pavers | |
| P.C.C / Plinth Protection | |
| Boundary Wall | |
| Brick Pavers / Soling | |
| Drain | |
| Tap | |
| Hand Pump | |
| Air Conditioner | |
| Tube Light | |
| Fan | |
| Roof Light | |
| Bulb | |

AREA

| | |
|---------------------------|---------------|
| AREA WITHIN BOUNDARY WALL | 210876.26 Sft |
| AREA OF CLINICAL BLOCK | 35635.8726Sft |
| PLINTH AREA OF BLOCK | 21845.8968Sft |

OPENING SCHEDULE OF DOORS AND WINDOWS

| DOORS | WIDTH | HEIGHT | WINDOWS | WIDTH | HEIGHT |
|-------|-------|--------|---------|-------|--------|
| D1 | 2'-0" | 7'-0" | W1 | 3'-0" | 5'-0" |
| D2 | 2'-6" | 7'-0" | W2 | 4'-0" | 4'-0" |
| D3 | 3'-0" | 7'-0" | W3 | 6'-0" | 6'-0" |
| D4 | 3'-6" | 7'-0" | W4 | 8'-0" | 8'-0" |
| D5 | 4'-0" | 7'-0" | W5 | 5'-0" | 5'-0" |
| D6 | 4'-6" | 7'-0" | W6 | | |
| D7 | 5'-0" | 7'-0" | W7 | | |
| D8 | 6'-0" | 7'-0" | V1 | 2'-0" | 2'-0" |
| D9 | 7'-0" | 7'-0" | V2 | | |

Project:
CAD MAPPING OF TEHSIL HEAD QUARTER HOSPITALS, PUNJAB

Client: GOVERNMENT OF THE PUNJAB
PRIMARY & SECONDARY HEALTHCARE DEPARTMENT


Consultant: SKAFS CONSULTANT (Pvt.) Limited
ENGINEERING AND ENVIRONMENT CONSULTANT

Drawing Title:
THQ SHABBIR SHARIF CLINICAL BLOCK PLAN (PART 4)

Drawing No. **SKAFS/SHABBIR SHARIF /12**

CLINICAL BLOCK OF THQ HOSPITAL SHABBIR SHARIF

FIRST FLOOR PART 1

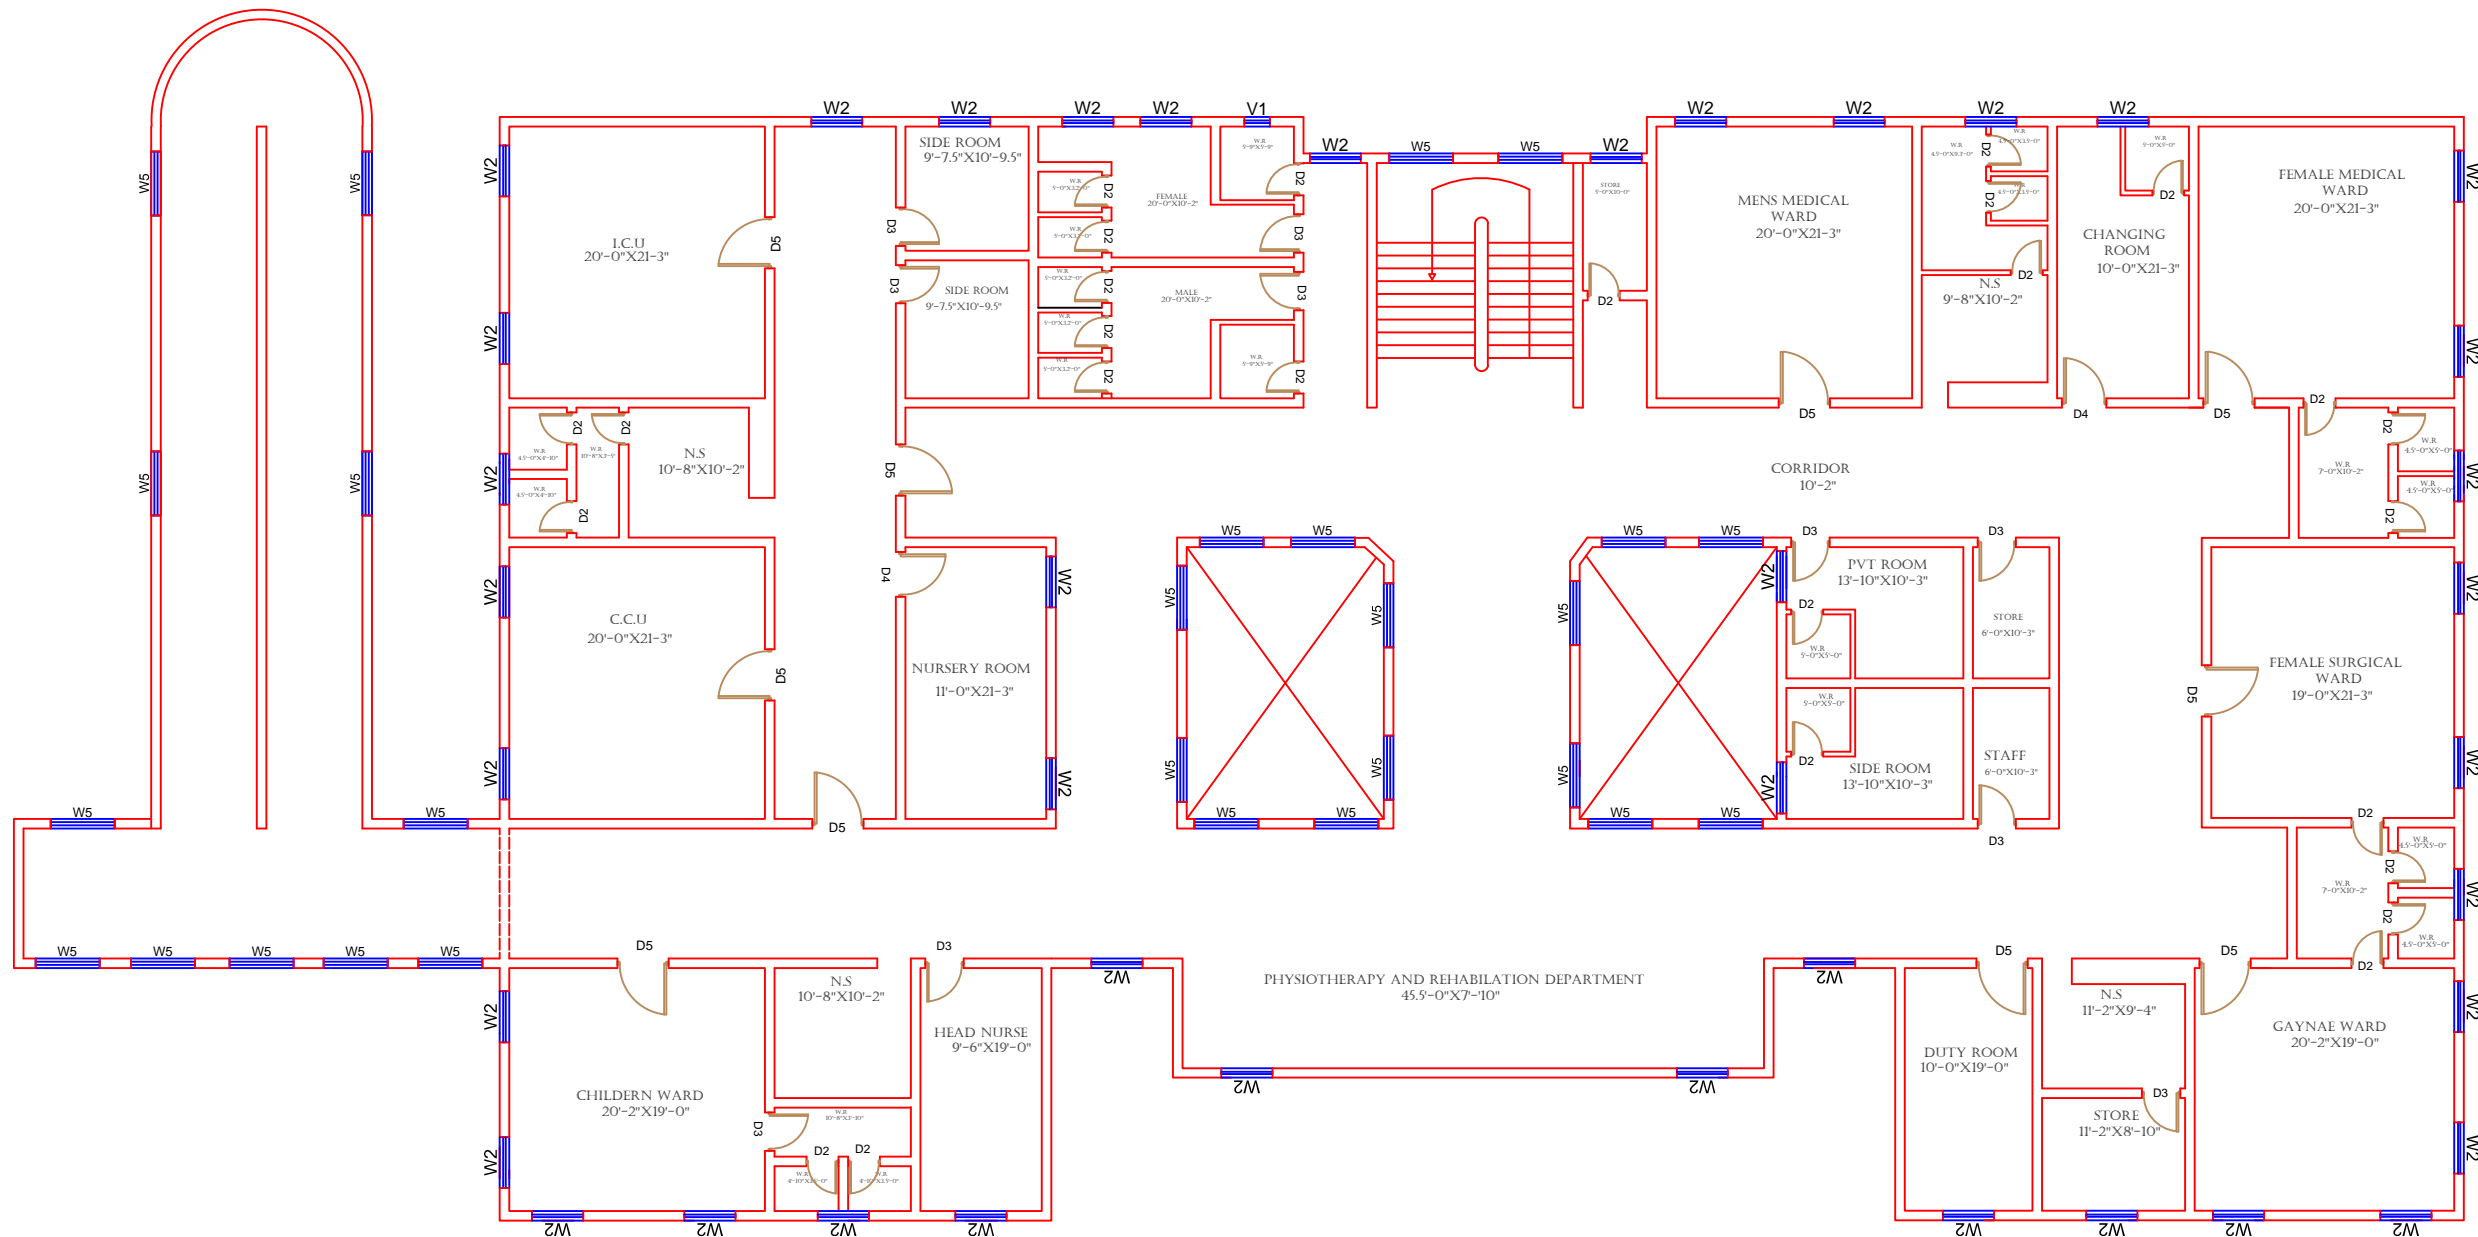

Legends:

| | |
|---------------------------|--|
| Residential Area | |
| Road | |
| Wall | |
| Power Line | |
| OHT | |
| Tree | |
| Man Hole | |
| Tube Well | |
| Light Pole | |
| Lawns | |
| Earthen Areas | |
| Asphalts Roads | |
| Tough Pavers | |
| P.C.C / Plinth Protection | |
| Boundary Wall | |
| Brick Pavers / Soling | |
| Drain | |
| Tap | |
| Hand Pump | |
| Air Conditioner | |
| Tube Light | |
| Fan | |
| Roof Light | |
| Bulb | |

| AREA | |
|---------------------------|----------------|
| AREA WITHIN BOUNDARY WALL | 210876.26 Sft |
| AREA OF CLINICAL BLOCK | 35635.8726 Sft |
| PLINTH AREA OF BLOCK | 21845.8968 Sft |

| OPENING SCHEDULE OF DOORS AND WINDOWS | | | | | |
|---------------------------------------|-------|--------|---------|-------|--------|
| DOORS | WIDTH | HEIGHT | WINDOWS | WIDTH | HEIGHT |
| D1 | 2'-0" | 7'-0" | W1 | 3'-0" | 5'-0" |
| D2 | 2'-6" | 7'-0" | W2 | 4'-0" | 4'-0" |
| D3 | 3'-0" | 7'-0" | W3 | 6'-0" | 6'-0" |
| D4 | 3'-6" | 7'-0" | W4 | 8'-0" | 8'-0" |
| D5 | 4'-0" | 7'-0" | W5 | 5'-0" | 5'-0" |
| D6 | 4'-6" | 7'-0" | W6 | | |
| D7 | 5'-0" | 7'-0" | W7 | | |
| D8 | 6'-0" | 7'-0" | V1 | 2'-0" | 2'-0" |
| D9 | 7'-0" | 7'-0" | V2 | | |


Project:
CAD MAPPING OF TEHSIL HEAD QUARTER HOSPITALS, PUNJAB

| | |
|---|--|
| Client: GOVERNMENT OF THE PUNJAB PRIMARY & SECONDARY HEALTHCARE DEPARTMENT | Consultant: SKAFS CONSULTANT (Pvt.) Limited ENGINEERING AND ENVIRONMENT CONSULTANT |
|---|--|

Drawing Title:
**THQ SHABBIR SHARIF
FIRST FLOOR PLAN (PART 1)**

Drawing No.
SKAFS/SHABBIR SHARIF /13

ELECTRICAL LAYOUT PLAN OF THQ HOSPITAL SHABBIR SHARIF GROUND FLOOR

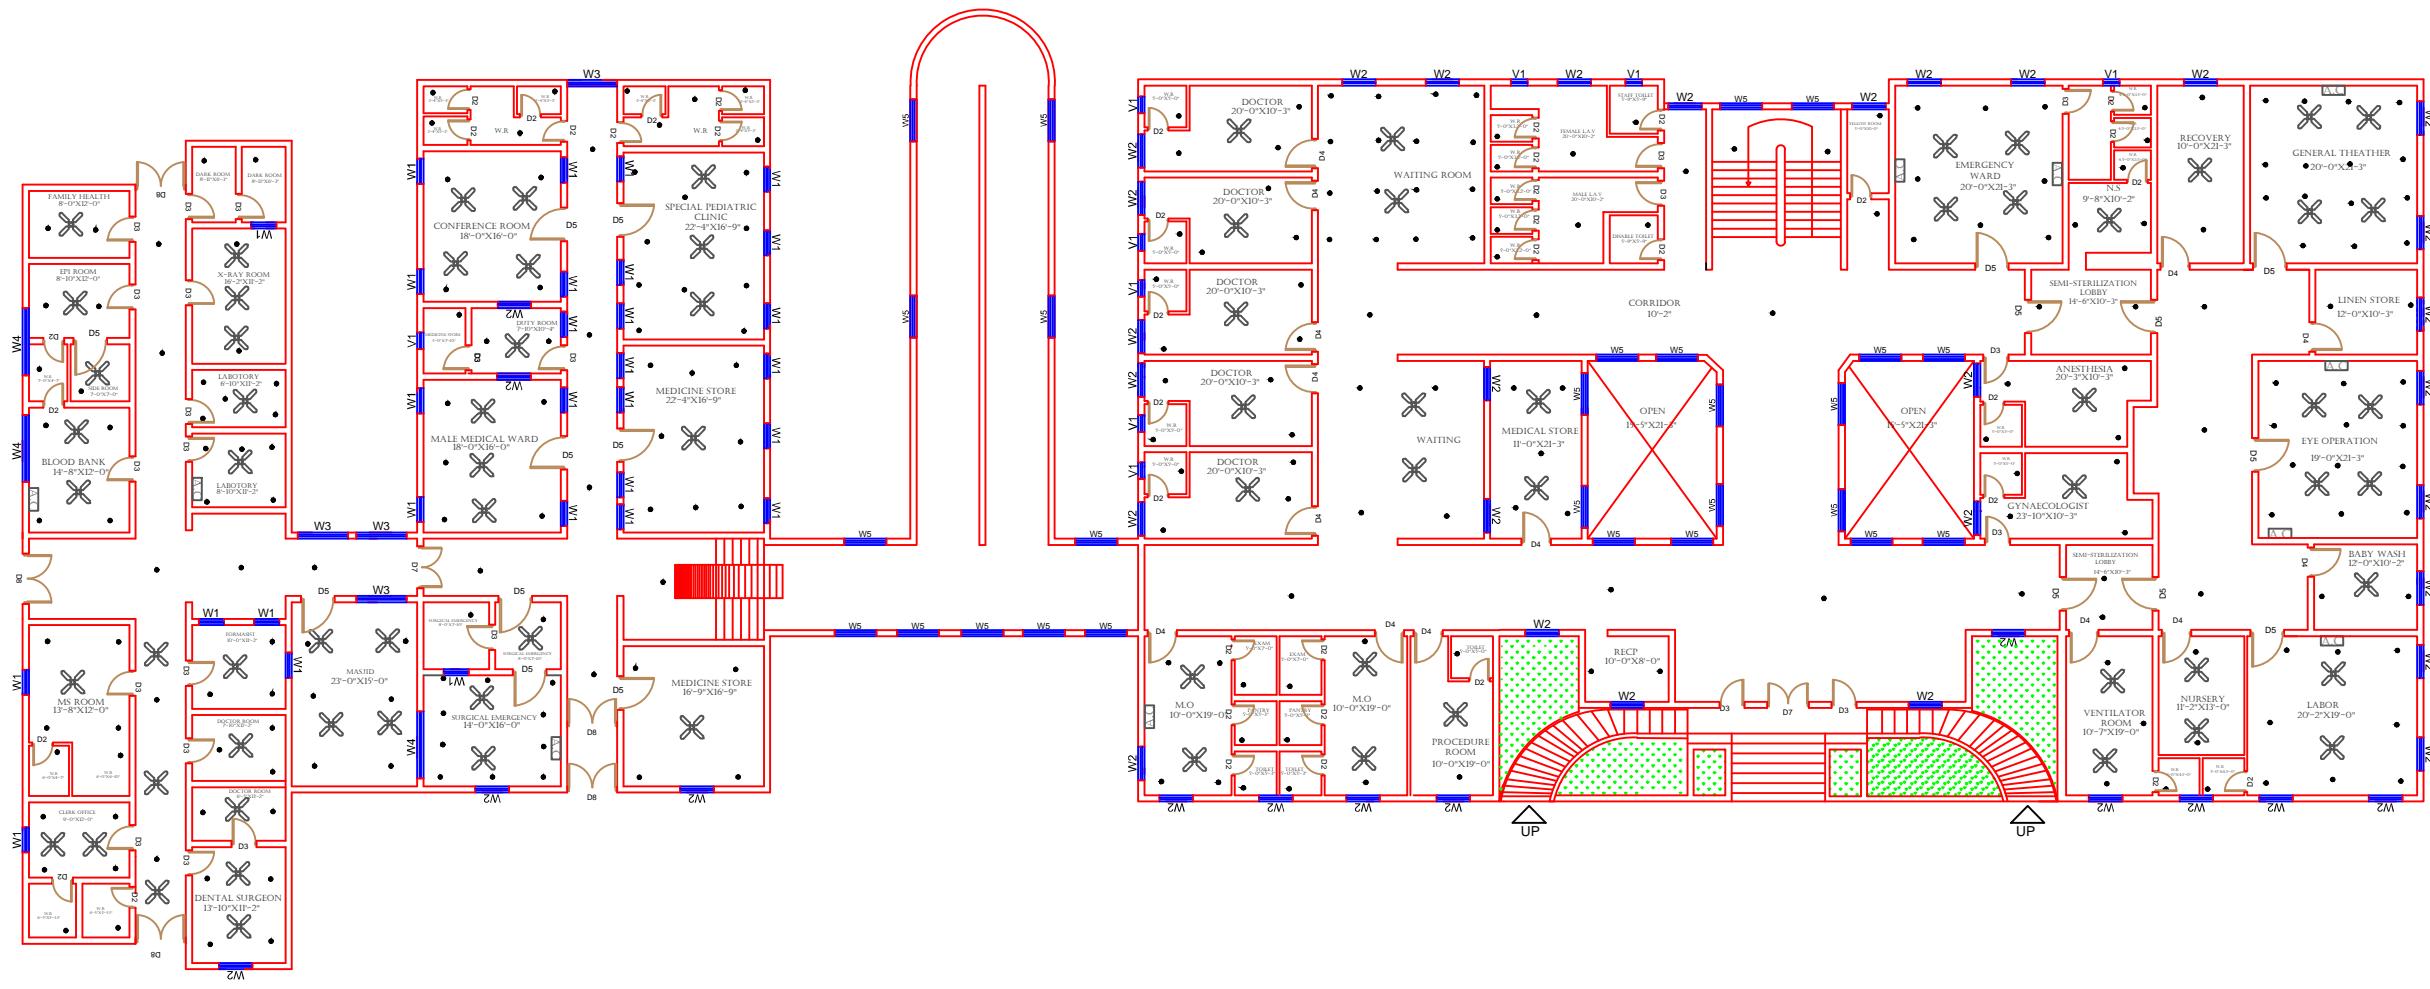

Legends:

| | |
|---------------------------|--|
| Residential Area | |
| Road | |
| Wall | |
| Power Line | |
| OHT | |
| Tree | |
| Man Hole | |
| Tube Well | |
| Light Pole | |
| Lawns | |
| Earthen Areas | |
| Asphalts Roads | |
| Tough Pavers | |
| P.C.C / Plinth Protection | |
| Boundary Wall | |
| Brick Pavers / Soling | |
| Drain | |
| Tap | |
| Hand Pump | |
| Air Conditioner | |
| Tube Light | |
| Fan | |
| Roof Light | |
| Bulb | |

| AREA | |
|---------------------------|----------------|
| AREA WITHIN BOUNDARY WALL | 210876.26 Sft |
| AREA OF CLINICAL BLOCK | 35635.8726 Sft |
| PLINTH AREA OF BLOCK | 21845.8968 Sft |

| OPENING SCHEDULE OF DOORS AND WINDOWS | | | | | |
|---------------------------------------|-------|--------|---------|-------|--------|
| DOORS | WIDTH | HEIGHT | WINDOWS | WIDTH | HEIGHT |
| D1 | 2'-0" | 7'-0" | W1 | 3'-0" | 5'-0" |
| D2 | 2'-6" | 7'-0" | W2 | 4'-0" | 4'-0" |
| D3 | 3'-0" | 7'-0" | W3 | 6'-0" | 6'-0" |
| D4 | 3'-6" | 7'-0" | W4 | 8'-0" | 8'-0" |
| D5 | 4'-0" | 7'-0" | W5 | 5'-0" | 5'-0" |
| D6 | 4'-6" | 7'-0" | W6 | | |
| D7 | 5'-0" | 7'-0" | W7 | | |
| D8 | 6'-0" | 7'-0" | V1 | 2'-0" | 2'-0" |
| D9 | 7'-0" | 7'-0" | V2 | | |

Project:
**CAD MAPPING OF TEHSIL
HEAD QUARTER HOSPITALS,
PUNJAB**


| | |
|---|--|
| Client: GOVERNMENT OF THE PUNJAB PRIMARY & SECONDARY HEALTHCARE DEPARTMENT | Consultant: SKAFS CONSULTANT (Pvt.) Limited ENGINEERING AND ENVIRONMENT CONSULTANT |
|---|--|

Drawing Title:
**THQ SHABBIR SHARIF
ELECTRICAL PLAN (GROUND FLOOR)**

Drawing No.
SKAFS/SHABBIR SHARIF /14

ELECTRICAL LAYOUT PLAN OF THQ HOSPITAL SHABBIR SHARIF FIRST FLOOR

FIRST FLOOR PLAN

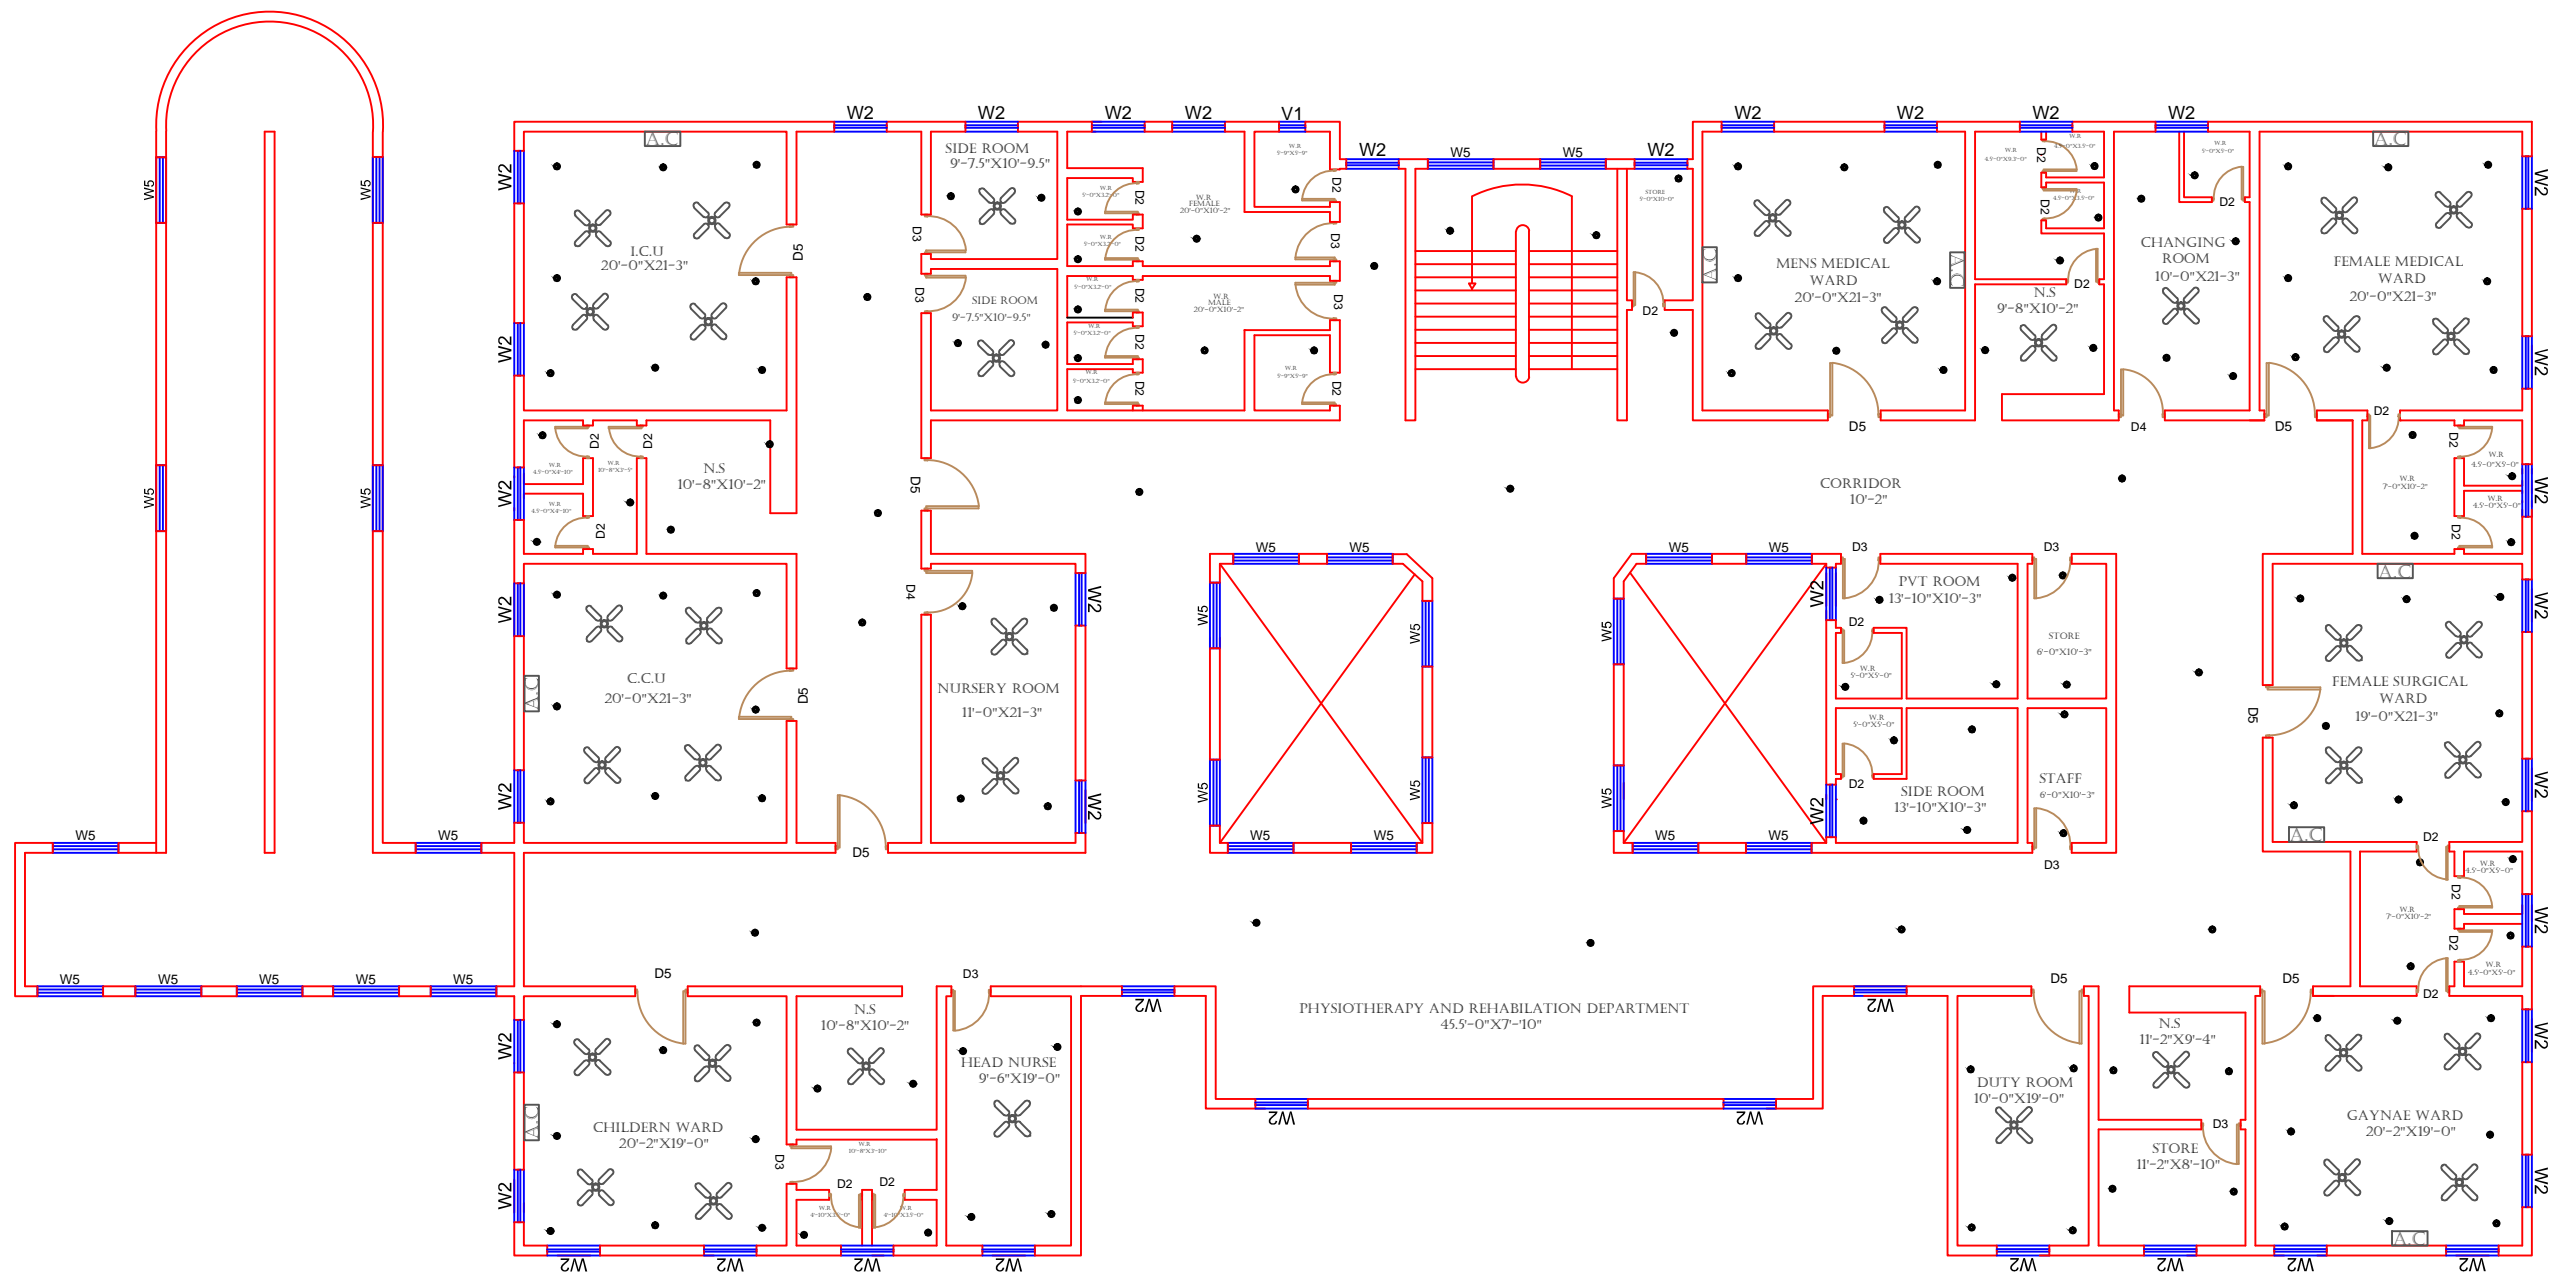

Legends:

| | |
|---------------------------|--|
| Residential Area | |
| Road | |
| Wall | |
| Power Line | |
| OHT | |
| Tree | |
| Man Hole | |
| Tube Well | |
| Light Pole | |
| Lawns | |
| Earthen Areas | |
| Asphalts Roads | |
| Tough Pavers | |
| P.C.C / Plinth Protection | |
| Boundary Wall | |
| Brick Pavers / Soling | |
| Drain | |
| Tap | |
| Hand Pump | |
| Air Conditioner | |
| Tube Light | |
| Fan | |
| Roof Light | |
| Bulb | |

| AREA | |
|---------------------------|----------------|
| AREA WITHIN BOUNDARY WALL | 210876.26 Sft |
| AREA OF CLINICAL BLOCK | 35635.8726 Sft |
| PLINTH AREA OF BLOCK | 21845.8968 Sft |

| OPENING SCHEDULE OF DOORS AND WINDOWS | | | | | |
|---------------------------------------|-------|--------|---------|-------|--------|
| DOORS | WIDTH | HEIGHT | WINDOWS | WIDTH | HEIGHT |
| D1 | 2'-0" | 7'-0" | W1 | 3'-0" | 5'-0" |
| D2 | 2'-6" | 7'-0" | W2 | 4'-0" | 4'-0" |
| D3 | 3'-0" | 7'-0" | W3 | 6'-0" | 6'-0" |
| D4 | 3'-6" | 7'-0" | W4 | 8'-0" | 8'-0" |
| D5 | 4'-0" | 7'-0" | W5 | 5'-0" | 5'-0" |
| D6 | 4'-6" | 7'-0" | W6 | | |
| D7 | 5'-0" | 7'-0" | W7 | | |
| D8 | 6'-0" | 7'-0" | V1 | 2'-0" | 2'-0" |
| D9 | 7'-0" | 7'-0" | V2 | | |

Project:
**CAD MAPPING OF TEHSIL
HEAD QUARTER HOSPITALS,
PUNJAB**

| | |
|---|--|
| Client: GOVERNMENT OF THE PUNJAB PRIMARY & SECONDARY HEALTHCARE DEPARTMENT | Consultant: SKAFS CONSULTANT (Pvt.) Limited ENGINEERING AND ENVIRONMENT CONSULTANT |
|---|--|

Drawing Title:
**THQ SHABBIR SHARIF
ELECTRICAL PLAN (FIRST FLOOR)**

Drawing No.
SKAFS/SHABBIR SHARIF /15