


# MASTER PLAN OF THQ HOSPITAL SHAHPUR

PART 1

PART 2

PART 3

PART 4

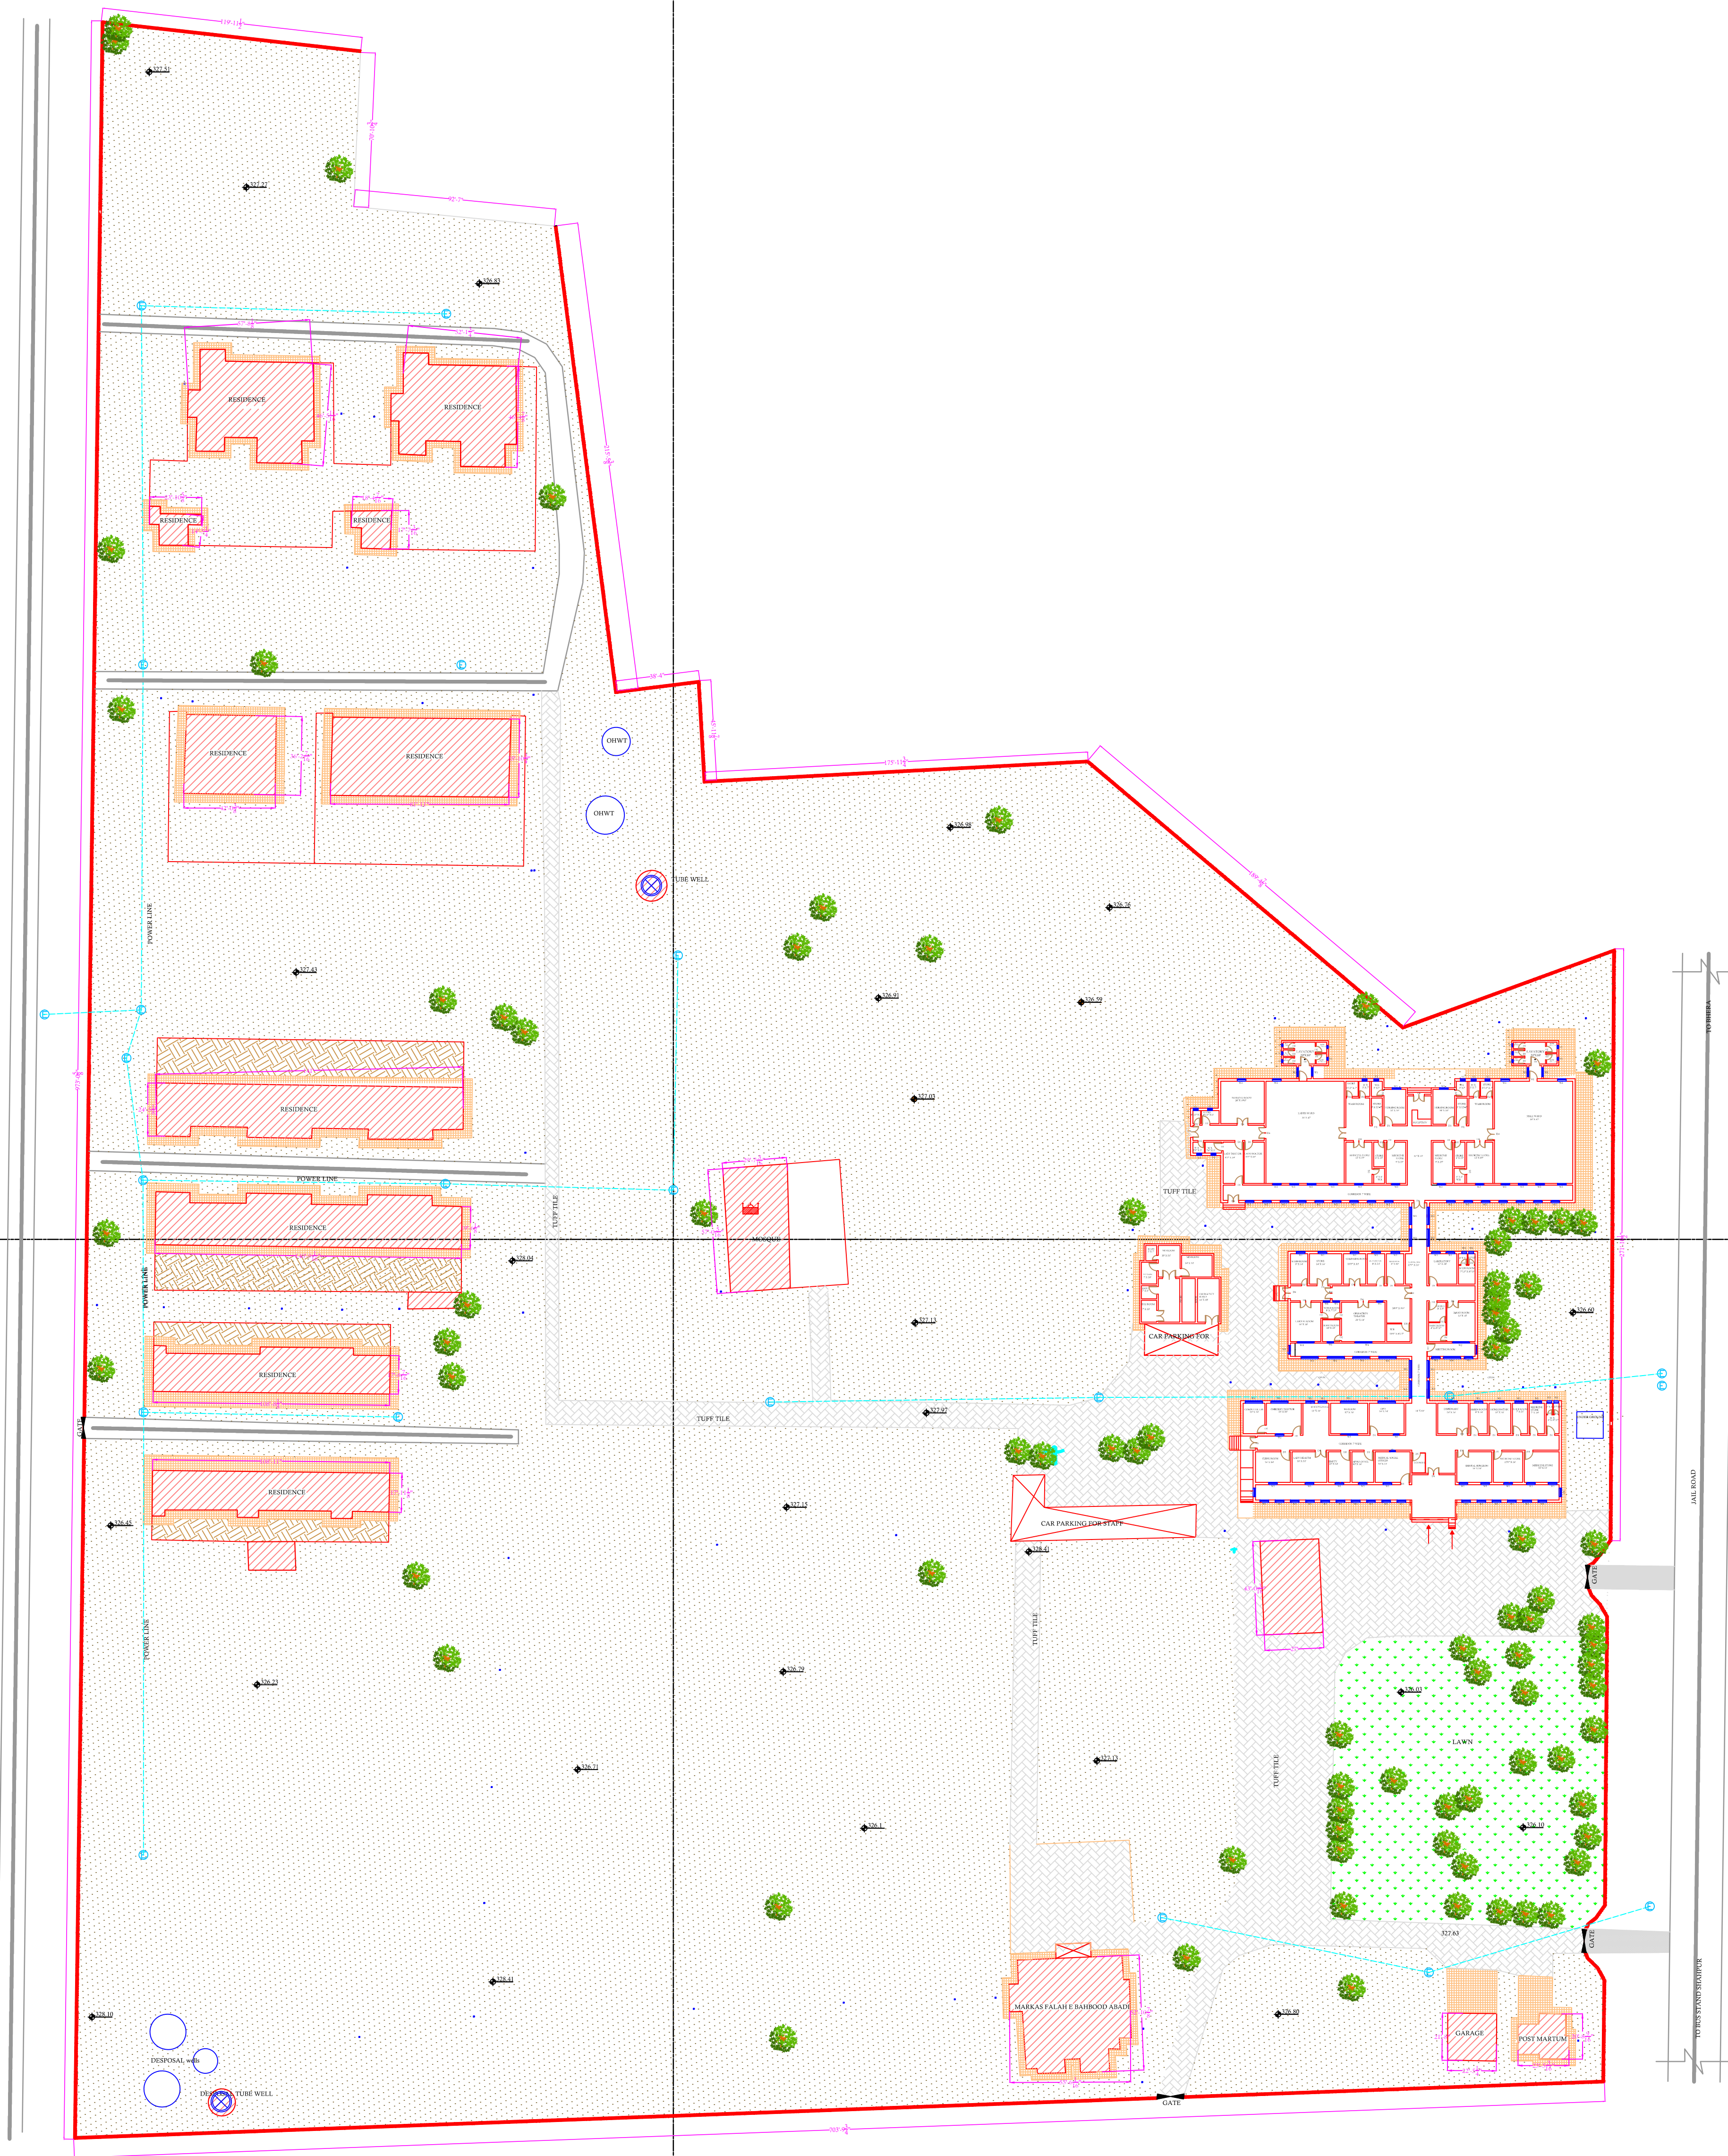

**Legends:**

Residential Area	
Road	
Wall	
Power Line	
OHT	
Tree	
ManHole	
Tube Well	
Light Pole	
Lawns	
Earthen Areas	
Asphalts Roads	
Tough Pavers	
P.C.C. /Plinth Protection	
Boundary Wall	
Tap	
Hand Pump	
BRICK Pavers	
Air Conditioner	
Tube Light	
Fan	
Roof Light	
Bulb	

AREA	
AREA WITHIN BOUNDARY WALL	483313.54Sft
AREA OF CLINICAL BLOCK	24204.00Sft
PLINTH AREA OF BLOCK	24204.00Sft

OPENING SCHEDULE OF DOORS AND WINDOWS					
DOORS	WIDTH	HEIGHT	WINDOWS	WIDTH	HEIGHT
D1	3'-6"	7'-0"	W1	4'-0"	4'-0"
D2	2'-6"	7'-0"	W2	6'-0"	6'-0"
D4	5'-0"	7'-0"	W3	2'-0"	2'-0"
D5	4'-0"	7'-0"	W4	8'-0"	8'-0"

**Client:**

**GOVERNMENT OF THE PUNJAB  
PRIMARY & SECONDARY  
HEALTHCARE DEPARTMENT**

**Project:**

**CAD MAPPING OF TEHSIL  
HEAD QUARTER HOSPITALS,  
PUNJAB**

**Consultant:**

**SKAFS CONSULTANT (Pvt.) Limited  
ENGINEERING AND ENVIRONMENT CONSULTANT**

**Drawing Title:**

**THQ SHAHPUR  
HOSPITAL MASTER PLAN**




 









 

 

 

 



Authorized By: SKAFS	Reviewed By Co-Team Leader	Scale: 1:500
Prepared By: CAD TEAMS	Date: FEB, 2017	
Drawing No. <b>SKAFS/SHAHPUR /03</b>		



# MASTER PLAN OF THQ HOSPITAL SHAHPUR

## PART 1



Legends:	
Residential Area	
Road	
Wall	
Power Line	
OHT	
Tree	
ManHole	
Tube Well	
Light Pole	
Lawns	
Earthen Areas	
Asphaltes Roads	
Tough Pavers	
P.C.C. /Plinth Protection	
Boundary Wall	
Tap	
Hand Pump	
BRICK Pavers	
Air Conditioner	
Tube Light	
Fan	
Roof Light	
Bulb	

AREA	
AREA WITHIN BOUNDARY WALL	483313.54Sft
AREA OF CLINICAL BLOCK	24204.00Sft
PLINTH AREA OF BLOCK	24204.00Sft

OPENING SCHEDULE OF DOORS AND WINDOWS					
DOORS	WIDTH	HEIGHT	WINDOWS	WIDTH	HEIGHT
D1	3'-6"	7'-0"	W1	4'-0"	4'-0"
D2	2'-6"	7'-0"	W2	6'-0"	6'-0"
D4	5'-0"	7'-0"	W3	2'-0"	2'-0"
D5	4'-0"	7'-0"	W4	8'-0"	8'-0"

Client:



GOVERNMENT OF THE PUNJAB  
PRIMARY & SECONDARY  
HEALTHCARE DEPARTMENT

Project:

## CAD MAPPING OF TEHSIL HEAD QUARTER HOSPITALS, PUNJAB

Consultant:



**SKAFS CONSULTANT (Pvt.) Limited**  
ENGINEERING AND ENVIRONMENT CONSULTANT

Drawing Title: **THQ SHAHPUR  
HOSPITAL MASTER PLAN  
PART 1**


Authorized By: SKAFS	Reviewed By Co-Team Leader	Scale:
Prepared By: CAD TEAMS	Date: FEB, 2017	Sheet:

Drawing No.	<b>SKAFS/SHAHPUR /04</b>
-------------	--------------------------



# MASTER PLAN OF THQ HOSPITAL SHAHPUR

## PART 2

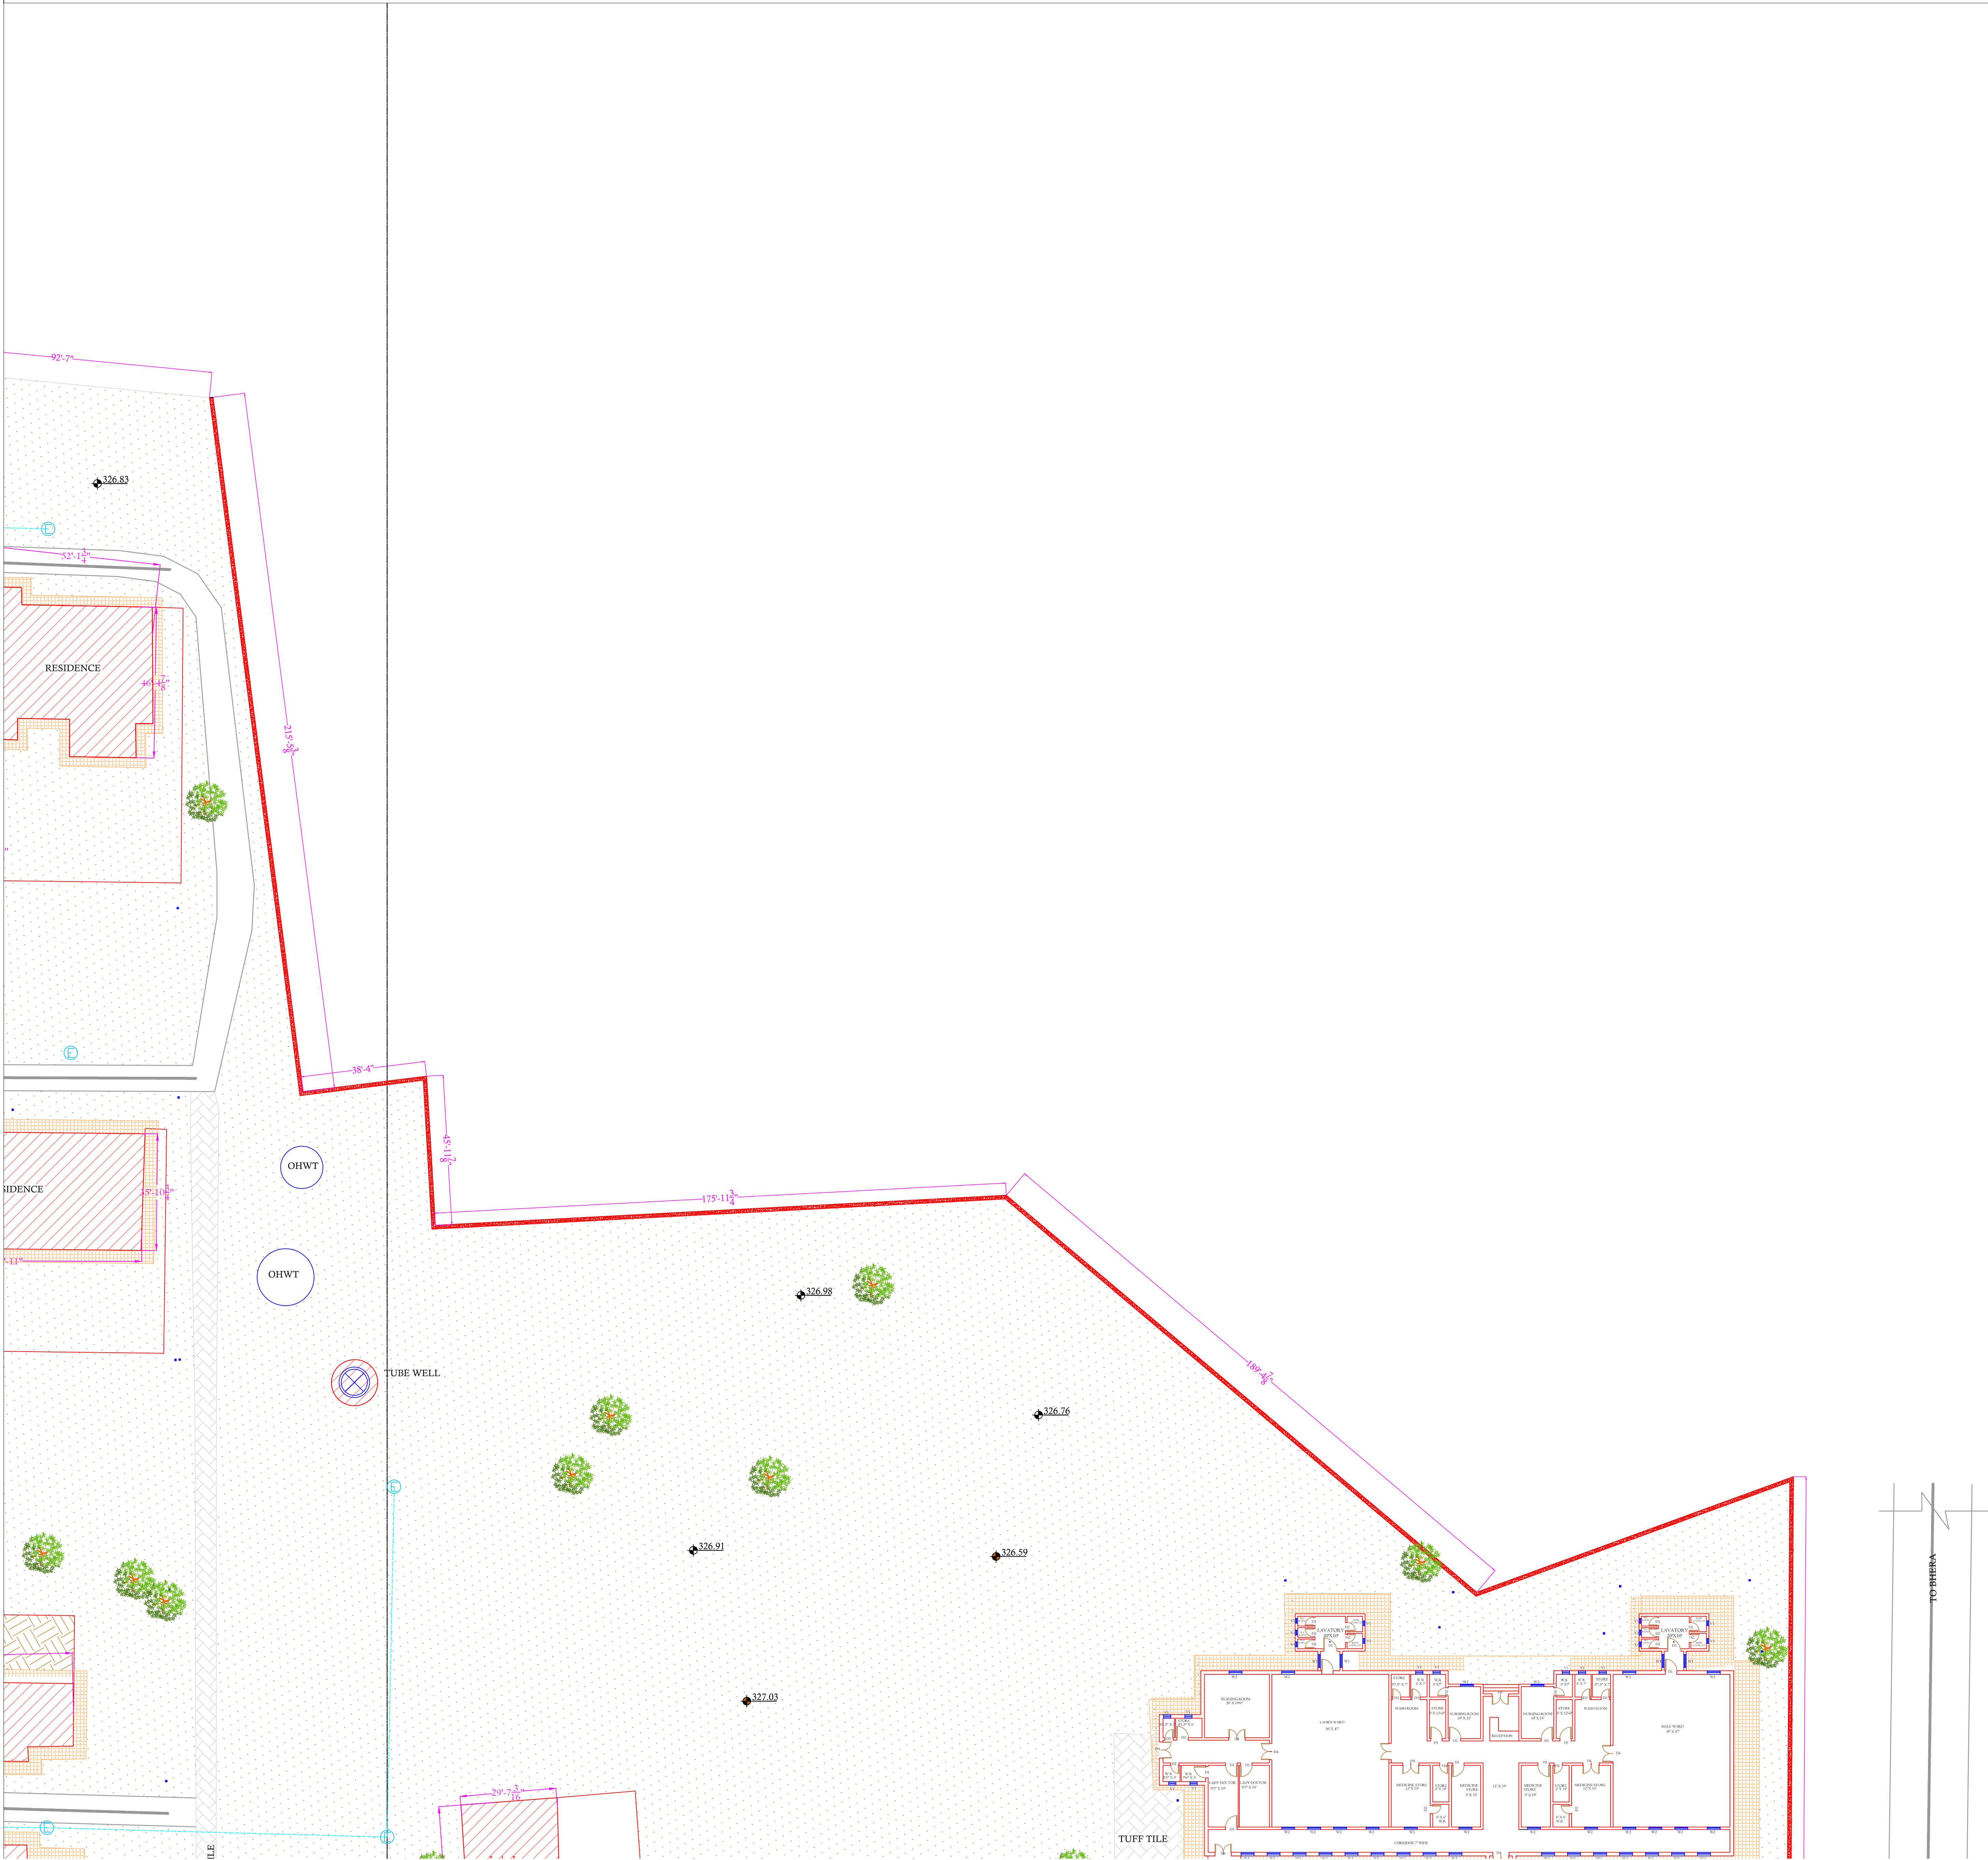

**Legends:**

Residential Area	
Road	
Wall	
Power Line	
OHT	
Tree	
ManHole	
Tube Well	
Light Pole	
Lawns	
Earthen Areas	
Asphalts Roads	
Tough Pavers	
P.C.C. /Plinth Protection	
Boundary Wall	
Tap	
Hand Pump	
BRICK Pavers	
Air Conditioner	
Tube Light	
Fan	
Roof Light	
Bulb	

AREA	
AREA WITHIN BOUNDARY WALL	483313.54Sft
AREA OF CLINICAL BLOCK	24204.00Sft
PLINTH AREA OF BLOCK	24204.00Sft

OPENING SCHEDULE OF DOORS AND WINDOWS					
DOORS	WIDTH	HEIGHT	WINDOWS	WIDTH	HEIGHT
D1	3'-6"	7'-0"	W1	4'-0"	4'-0"
D2	2'-6"	7'-0"	W2	6'-0"	6'-0"
D4	5'-0"	7'-0"	W3	2'-0"	2'-0"
D5	4'-0"	7'-0"	W4	8'-0"	8'-0"

Client:



**GOVERNMENT OF THE PUNJAB**  
**PRIMARY & SECONDARY**  
**HEALTHCARE DEPARTMENT**

Project:

**CAD MAPPING OF TEHSIL**  
**HEAD QUARTER HOSPITALS,**  
**PUNJAB**

Consultant:



**SKAFS CONSULTANT (Pvt.) Limited**  
ENGINEERING AND ENVIRONMENT CONSULTANT

Drawing Title:

**THQ SHAHPUR**  
**HOSPITAL MASTER PLAN**  
**PART 2**

Authorized By: SKAFS	Reviewed By Co-Team Leader	Scale:
Prepared By: CAD TEAMS	Date: FEB, 2017	Sheet:
Drawing No.		<b>SKAFS/SHAHPUR /05</b>



# MASTER PLAN OF THQ HOSPITAL SHAHPUR

## PART 3



**Legends:**

Residential Area	
Road	
Wall	
Power Line	
OHT	
Tree	
ManHole	
Tube Well	
Light Pole	
Lawns	
Earthen Areas	
Asphalts Roads	
Tough Pavers	
P.C.C. /Plinth Protection	
Boundary Wall	
Tap	
Hand Pump	
BRICK Pavers	
Air Conditioner	
Tube Light	
Fan	
Roof Light	
Bulb	

AREA	
AREA WITHIN BOUNDARY WALL	483313.54Sft
AREA OF CLINICAL BLOCK	24204.00Sft
PLINTH AREA OF BLOCK	24204.00Sft

OPENING SCHEDULE OF DOORS AND WINDOWS					
DOORS	WIDTH	HEIGHT	WINDOWS	WIDTH	HEIGHT
D1	3'-6"	7'-0"	W1	4'-0"	4'-0"
D2	2'-6"	7'-0"	W2	6'-0"	6'-0"
D4	5'-0"	7'-0"	W3	2'-0"	2'-0"
D5	4'-0"	7'-0"	W4	8'-0"	8'-0"

Client:

GOVERNMENT OF THE PUNJAB  
PRIMARY & SECONDARY  
HEALTHCARE DEPARTMENT

Project:

CAD MAPPING OF TEHSIL  
HEAD QUARTER HOSPITALS,  
PUNJAB

Consultant:

SKAFS CONSULTANT (Pvt.) Limited  
ENGINEERING AND ENVIRONMENT CONSULTANT

Drawing Title:

THQ SHAHPUR  
HOSPITAL MASTER PLAN  
PART 3


Authorized By: SKAFS	Reviewed By Co-Team Leader	Scale:
Prepared By: CAD TEAMS	Date: FEB, 2017	
Drawing No.		

SKAFS/SHAHPUR /06



# MASTER PLAN OF THQ HOSPITAL SHAHPUR

## PART 4

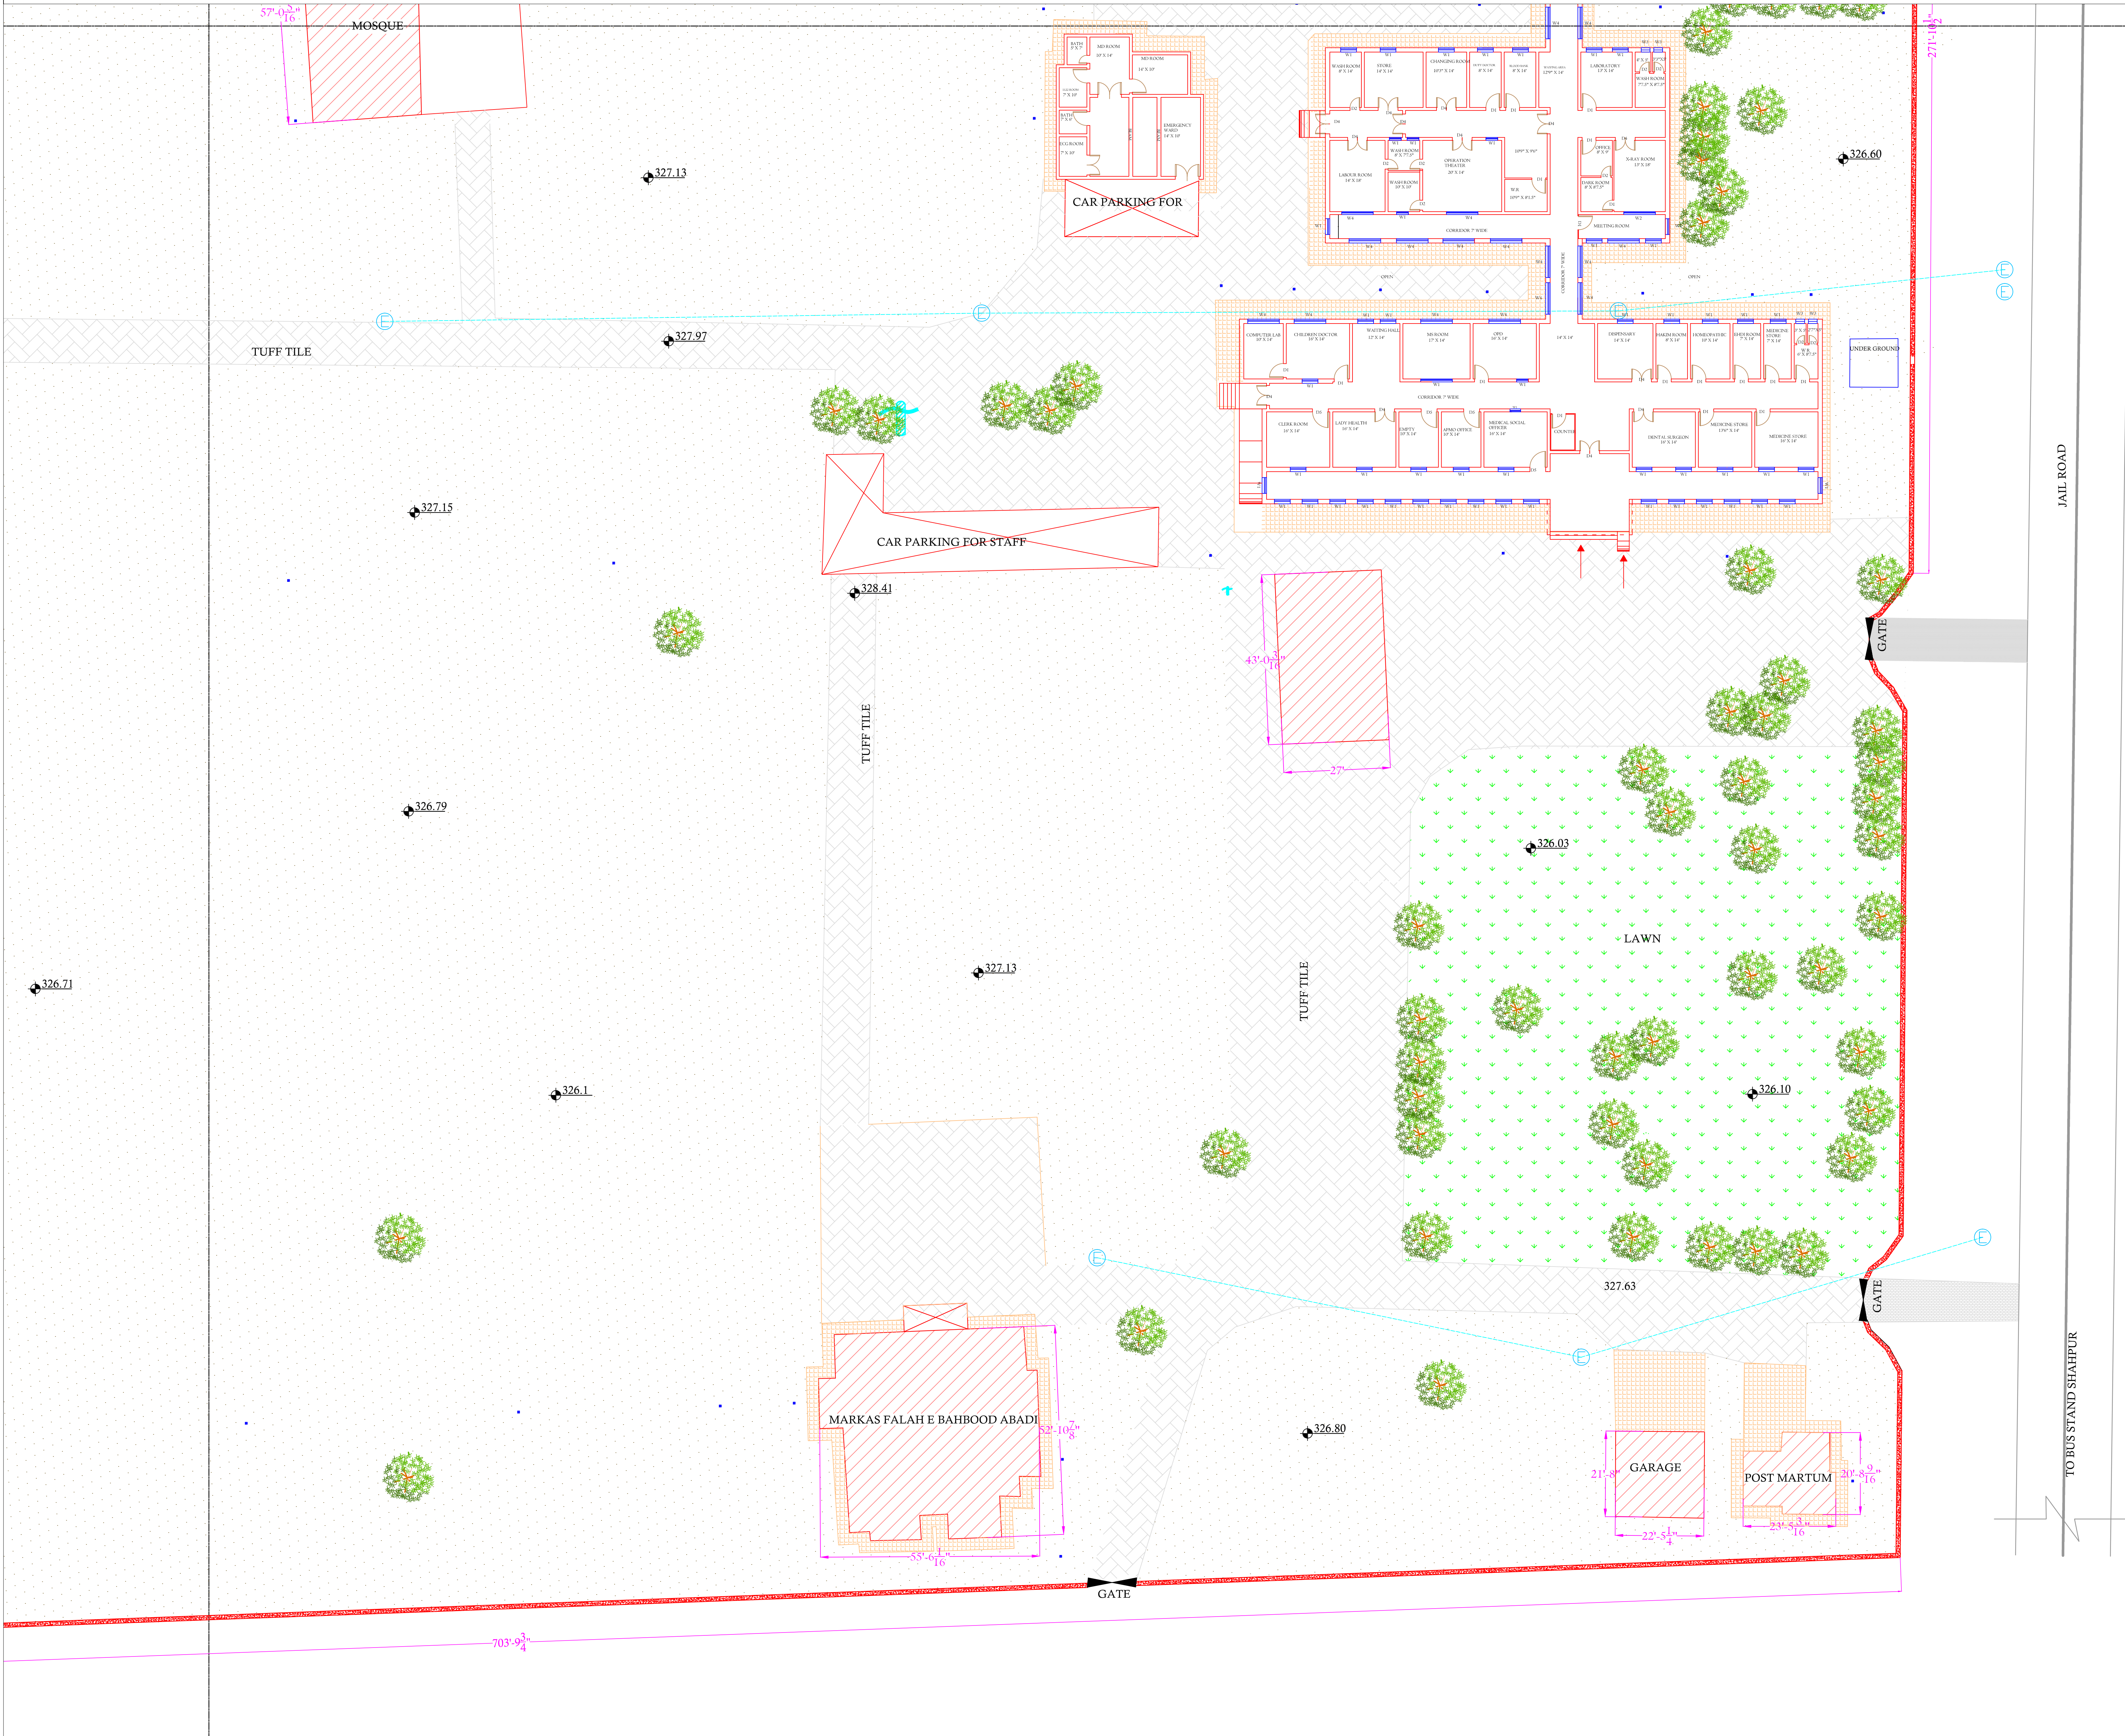

**Legends:**

Residential Area	
Road	
Wall	
Power Line	
OHT	
Tree	
ManHole	
Tube Well	
Light Pole	
Lawns	
Earthen Areas	
Asphalts Roads	
Tough Pavers	
P.C.C. /Plinth Protection	
Boundary Wall	
Tap	
Hand Pump	
BRICK Pavers	
Air Conditioner	
Tube Light	
Fan	
Roof Light	
Bulb	

AREA	
AREA WITHIN BOUNDARY WALL	483313.54Sft
AREA OF CLINICAL BLOCK	24204.00Sft
PLINTH AREA OF BLOCK	24204.00Sft

OPENING SCHEDULE OF DOORS AND WINDOWS					
DOORS	WIDTH	HEIGHT	WINDOWS	WIDTH	HEIGHT
D1	3'-6"	7'-0"	W1	4'-0"	4'-0"
D2	2'-6"	7'-0"	W2	6'-0"	6'-0"
D4	5'-0"	7'-0"	W3	2'-0"	2'-0"
D5	4'-0"	7'-0"	W4	8'-0"	8'-0"

Client:



GOVERNMENT OF THE PUNJAB  
PRIMARY & SECONDARY  
HEALTHCARE DEPARTMENT

Project:

CAD MAPPING OF TEHSIL  
HEAD QUARTER HOSPITALS,  
PUNJAB

Consultant:



SKAFS CONSULTANT (Pvt.) Limited  
ENGINEERING AND ENVIRONMENT CONSULTANT

Drawing Title:

THQ SHAHPUR  
HOSPITAL MASTER PLAN  
PART 4

Authorized By: SKAFS	Reviewed By Co-Team Leader	Scale:
Prepared By: CAD TEAMS	Date: FEB, 2017	
Drawing No.		SKAFS/SHAHPUR /07




# CLINICAL BLOCK OF THQ HOSPITAL SHAHPUR

## GROUND FLOOR


PART 1

PART 2

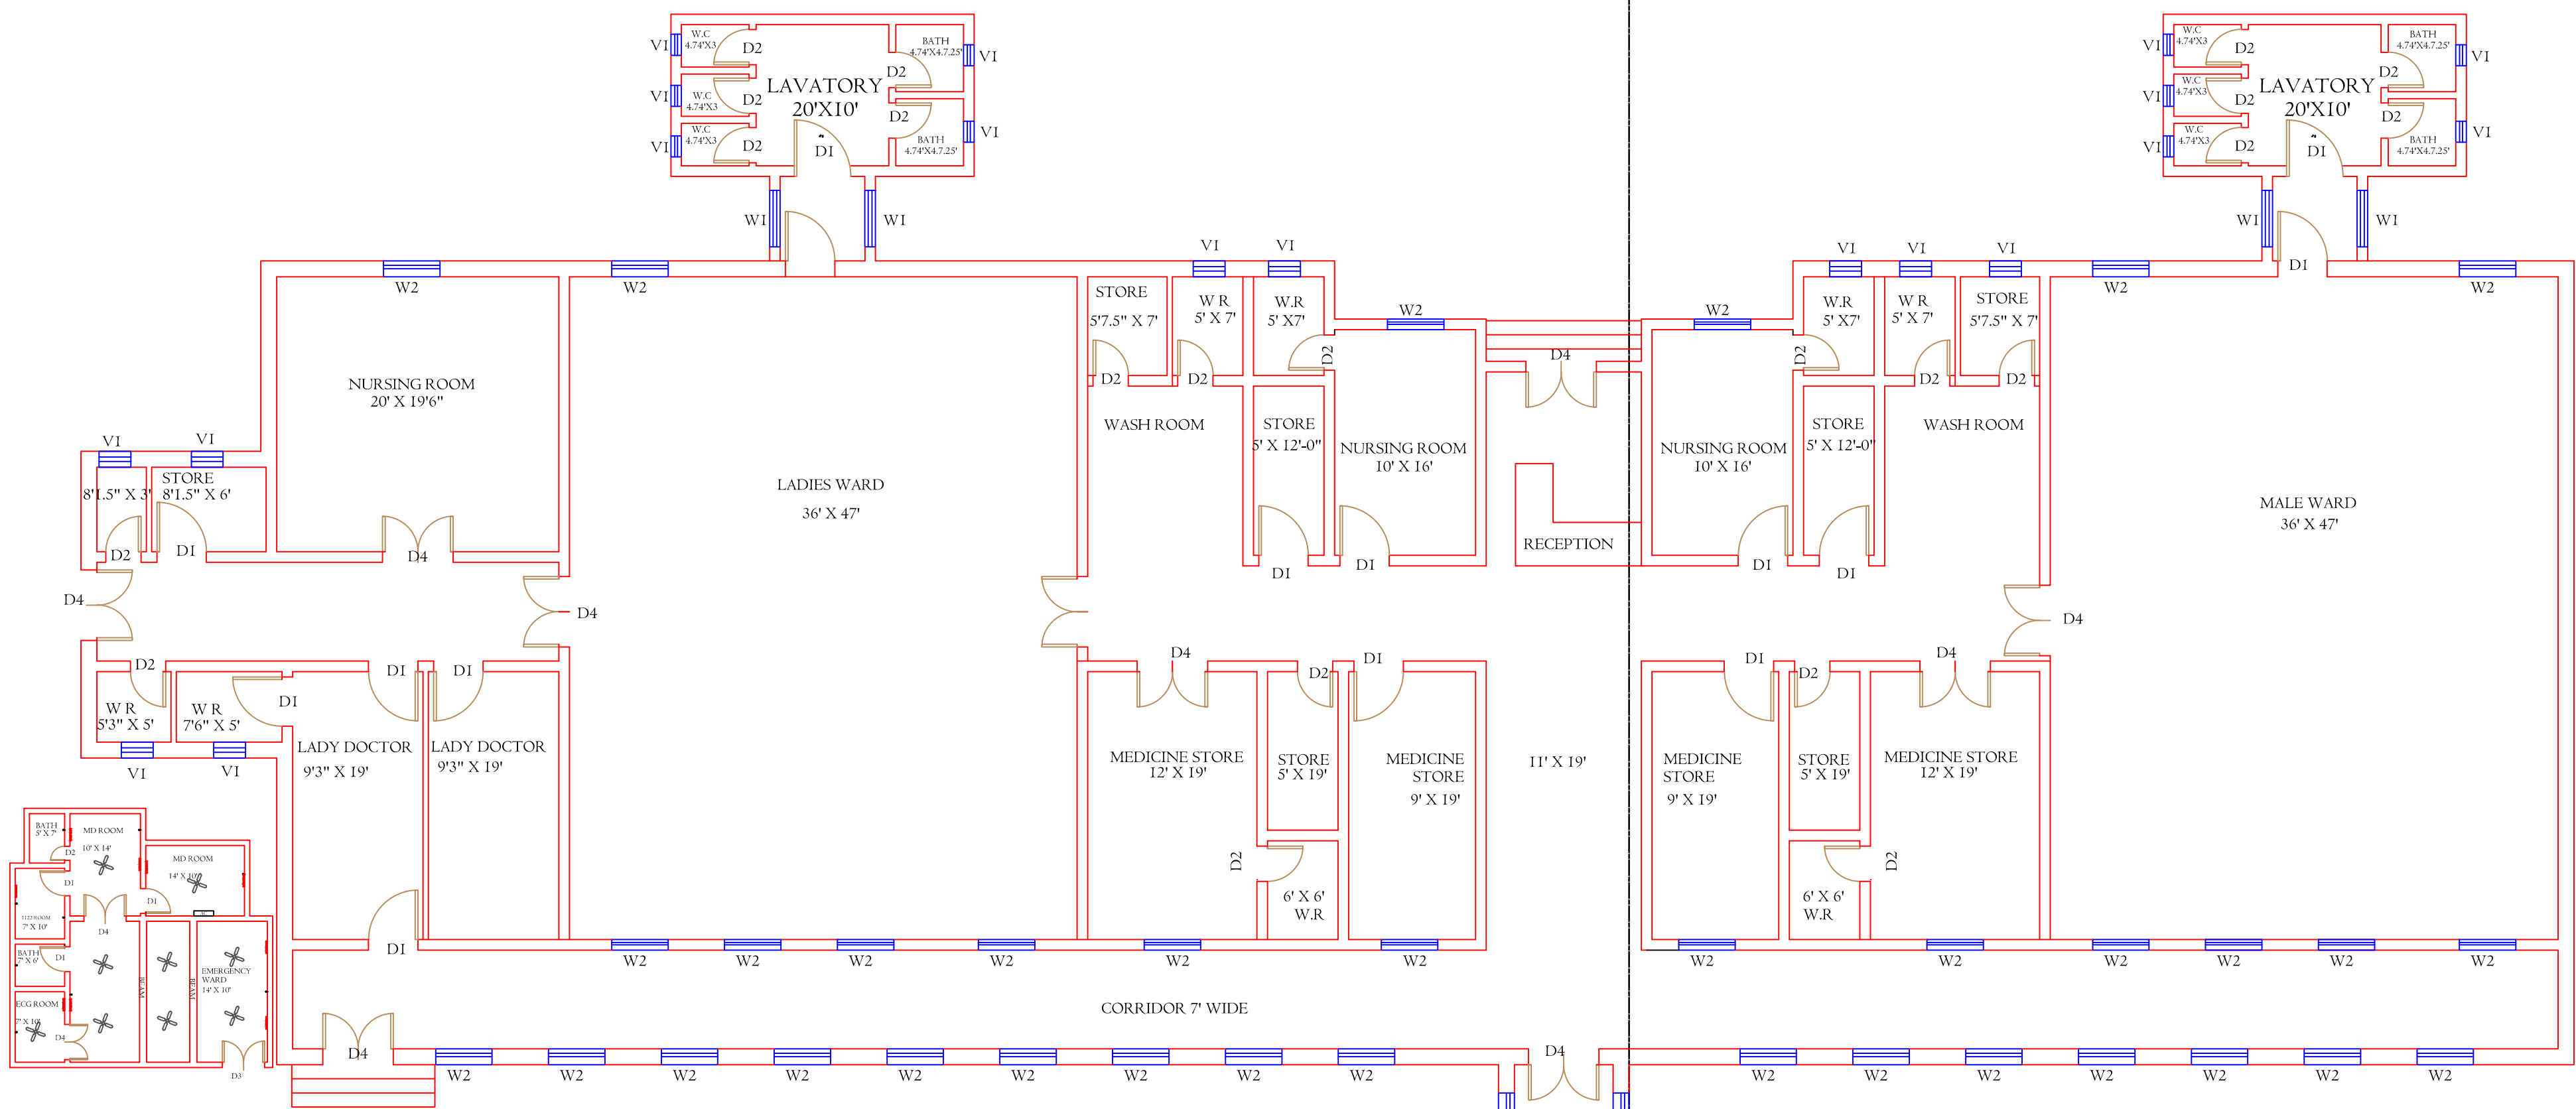

PART 3

PART 4

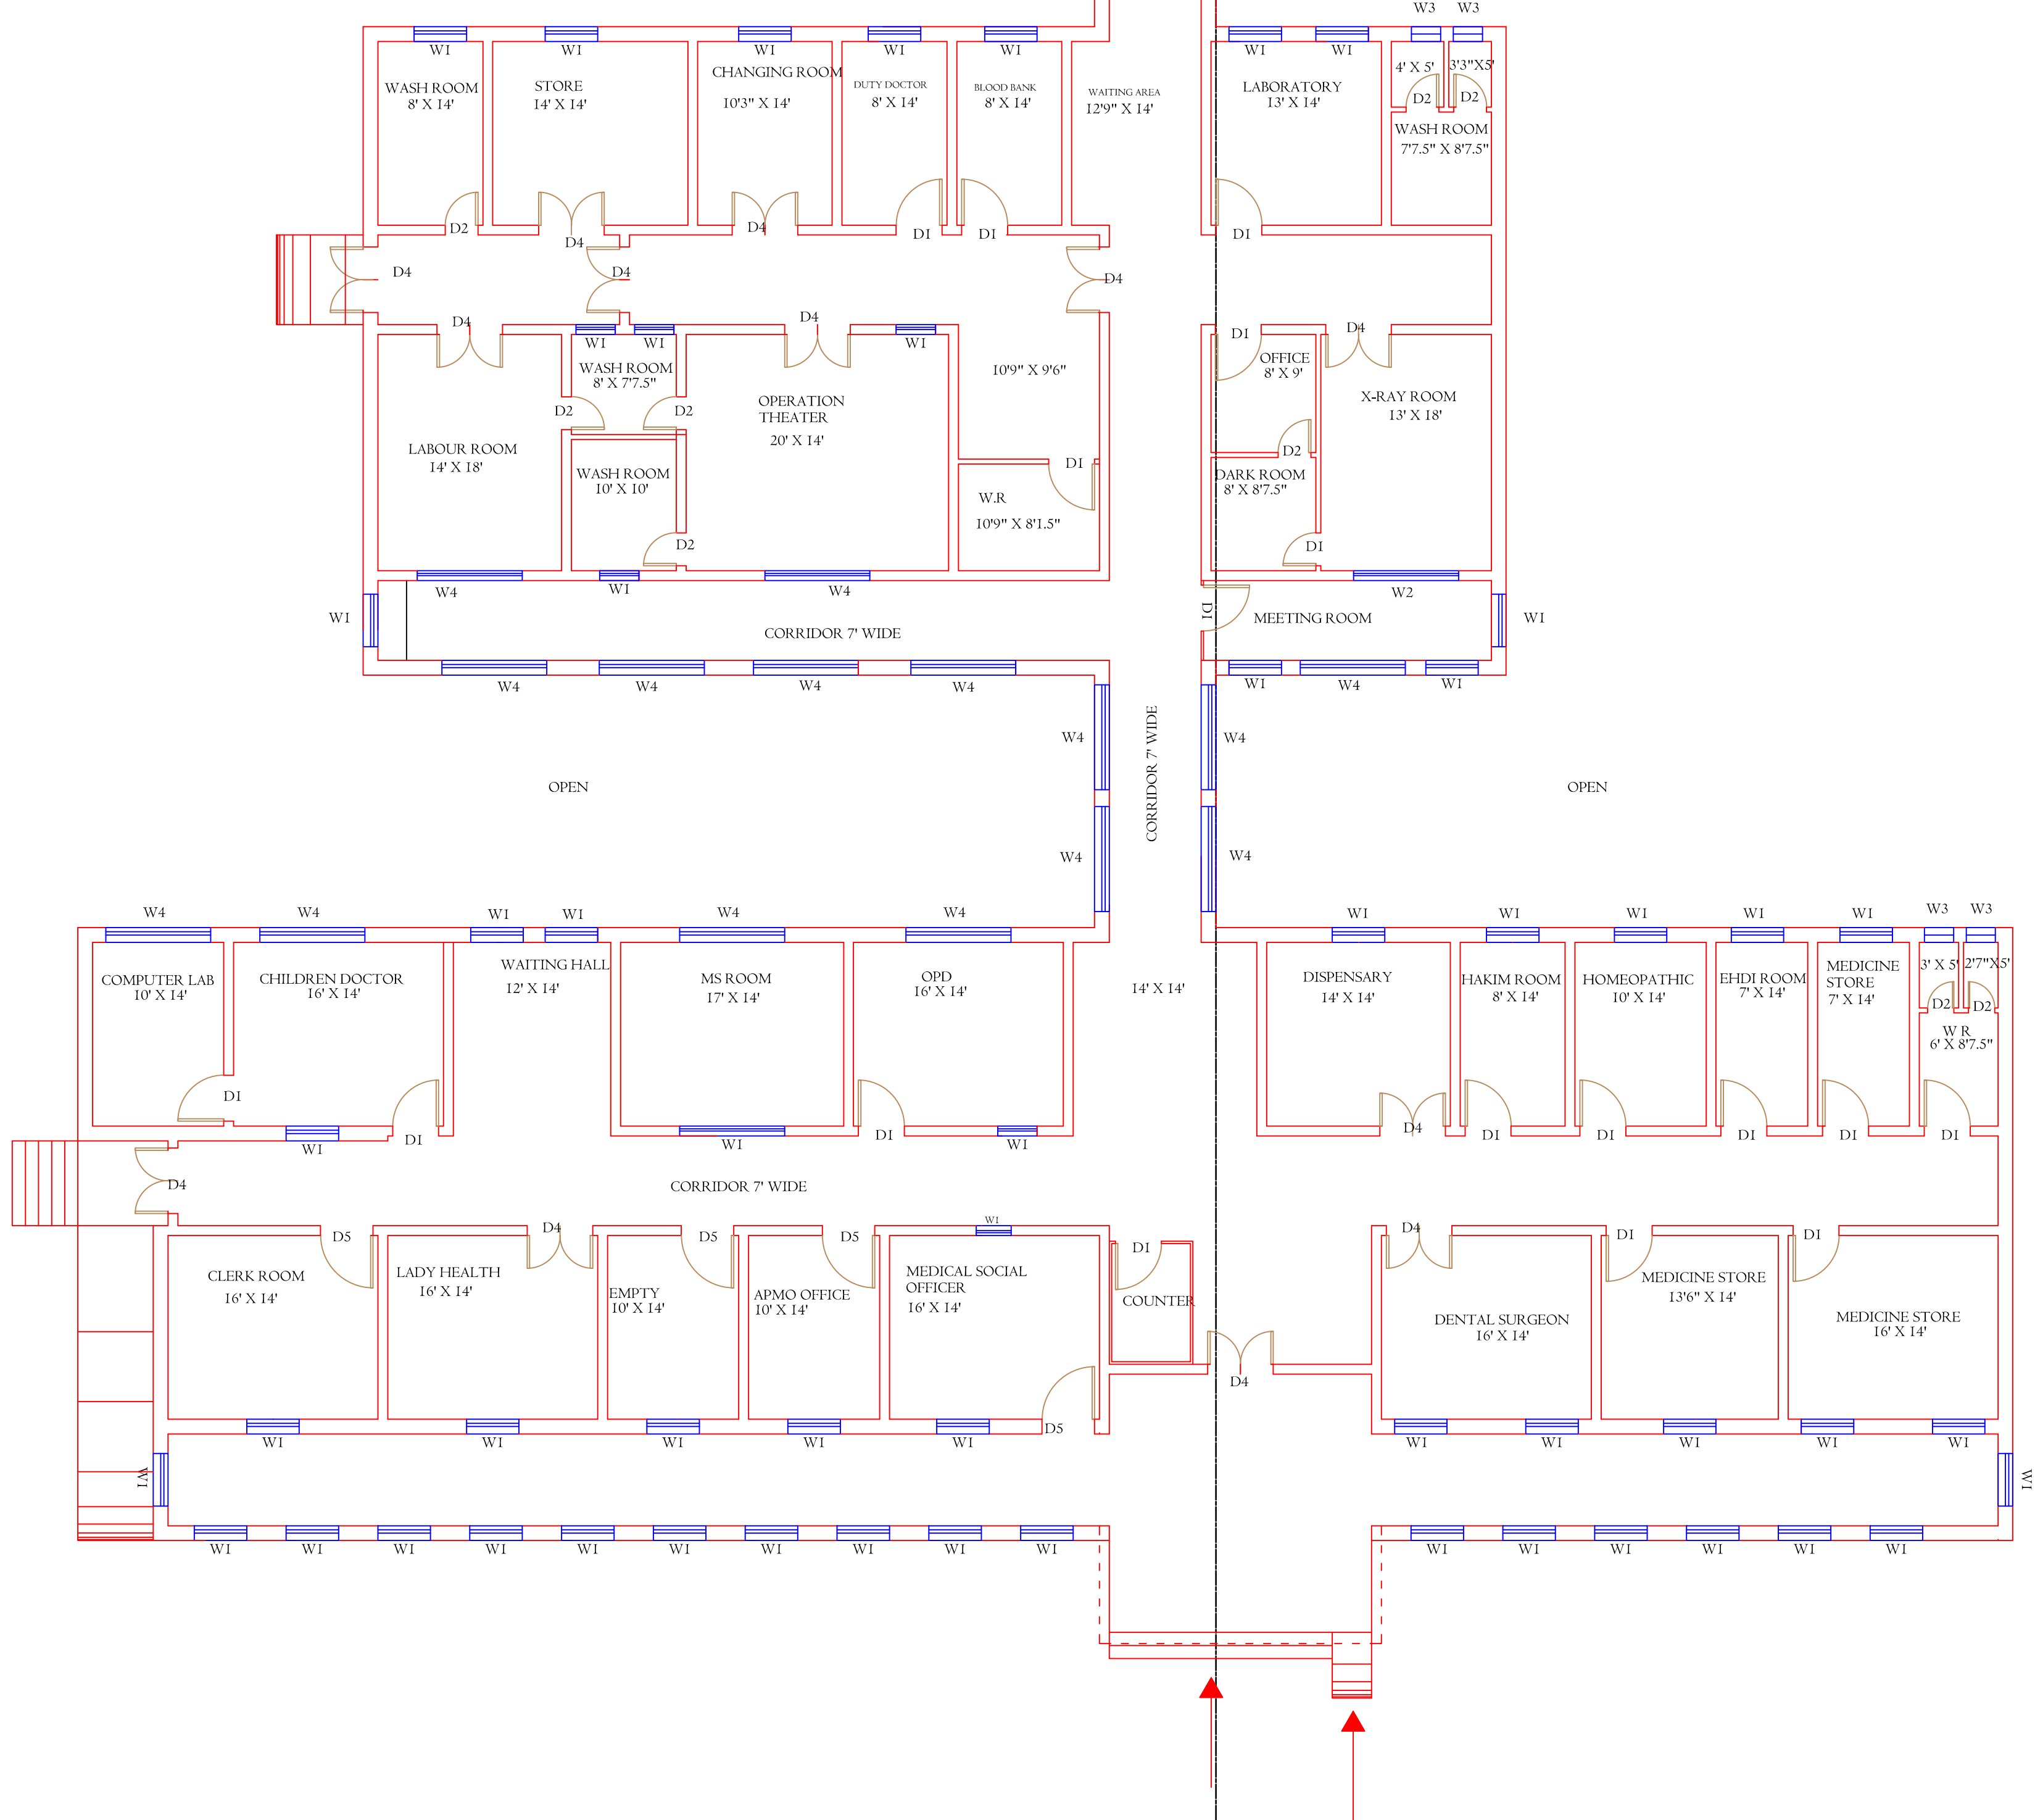


**Legends:**

Residential Area	
Road	
Wall	
Power Line	
OHT	
Tree	
ManHole	
Tube Well	
Light Pole	
Lawns	
Earthen Areas	
Asphalts Roads	
Tough Pavers	
P.C.C. /Plinth Protection	
Boundary Wall	
Tap	
Hand Pump	
BRICK Pavers	
Air Conditioner	
Tube Light	
Fan	
Roof Light	
Bulb	

AREA	
AREA WITHIN BOUNDARY WALL	483313.54Sft
AREA OF CLINICAL BLOCK	24204.00Sft
PLINTH AREA OF BLOCK	24204.00Sft

OPENING SCHEDULE OF DOORS AND WINDOWS					
DOORS	WIDTH	HEIGHT	WINDOWS	WIDTH	HEIGHT
D1	3'-6"	7'-0"	W1	4'-0"	4'-0"
D2	2'-6"	7'-0"	W2	6'-0"	6'-0"
D4	5'-0"	7'-0"	W3	2'-0"	2'-0"
D5	4'-0"	7'-0"	W4	8'-0"	8'-0"

**Client:**




**GOVERNMENT OF THE PUNJAB  
PRIMARY & SECONDARY  
HEALTHCARE DEPARTMENT**

**Project:**

**CAD MAPPING OF TEHSIL  
HEAD QUARTER HOSPITALS,  
PUNJAB**

**Consultant:**



**SKAFS CONSULTANT (Pvt.) Limited  
ENGINEERING AND ENVIRONMENT CONSULTANT**

**Drawing Title:**

**THQ SHAHPUR  
HOSPITAL MAIN BUILDING  
CLINICAL BLOCK PLAN**


Authorized By: SKAFS	Reviewed By Co-Team Leader	Scale:
Prepared By: CAD TEAMS	Date: FEB, 2017	
Drawing No.		

**SKAFS/SHAHPUR /08**



# CLINICAL BLOCK OF THQ HOSPITAL MAILSI

## GROUND FLOOR (PART 1)

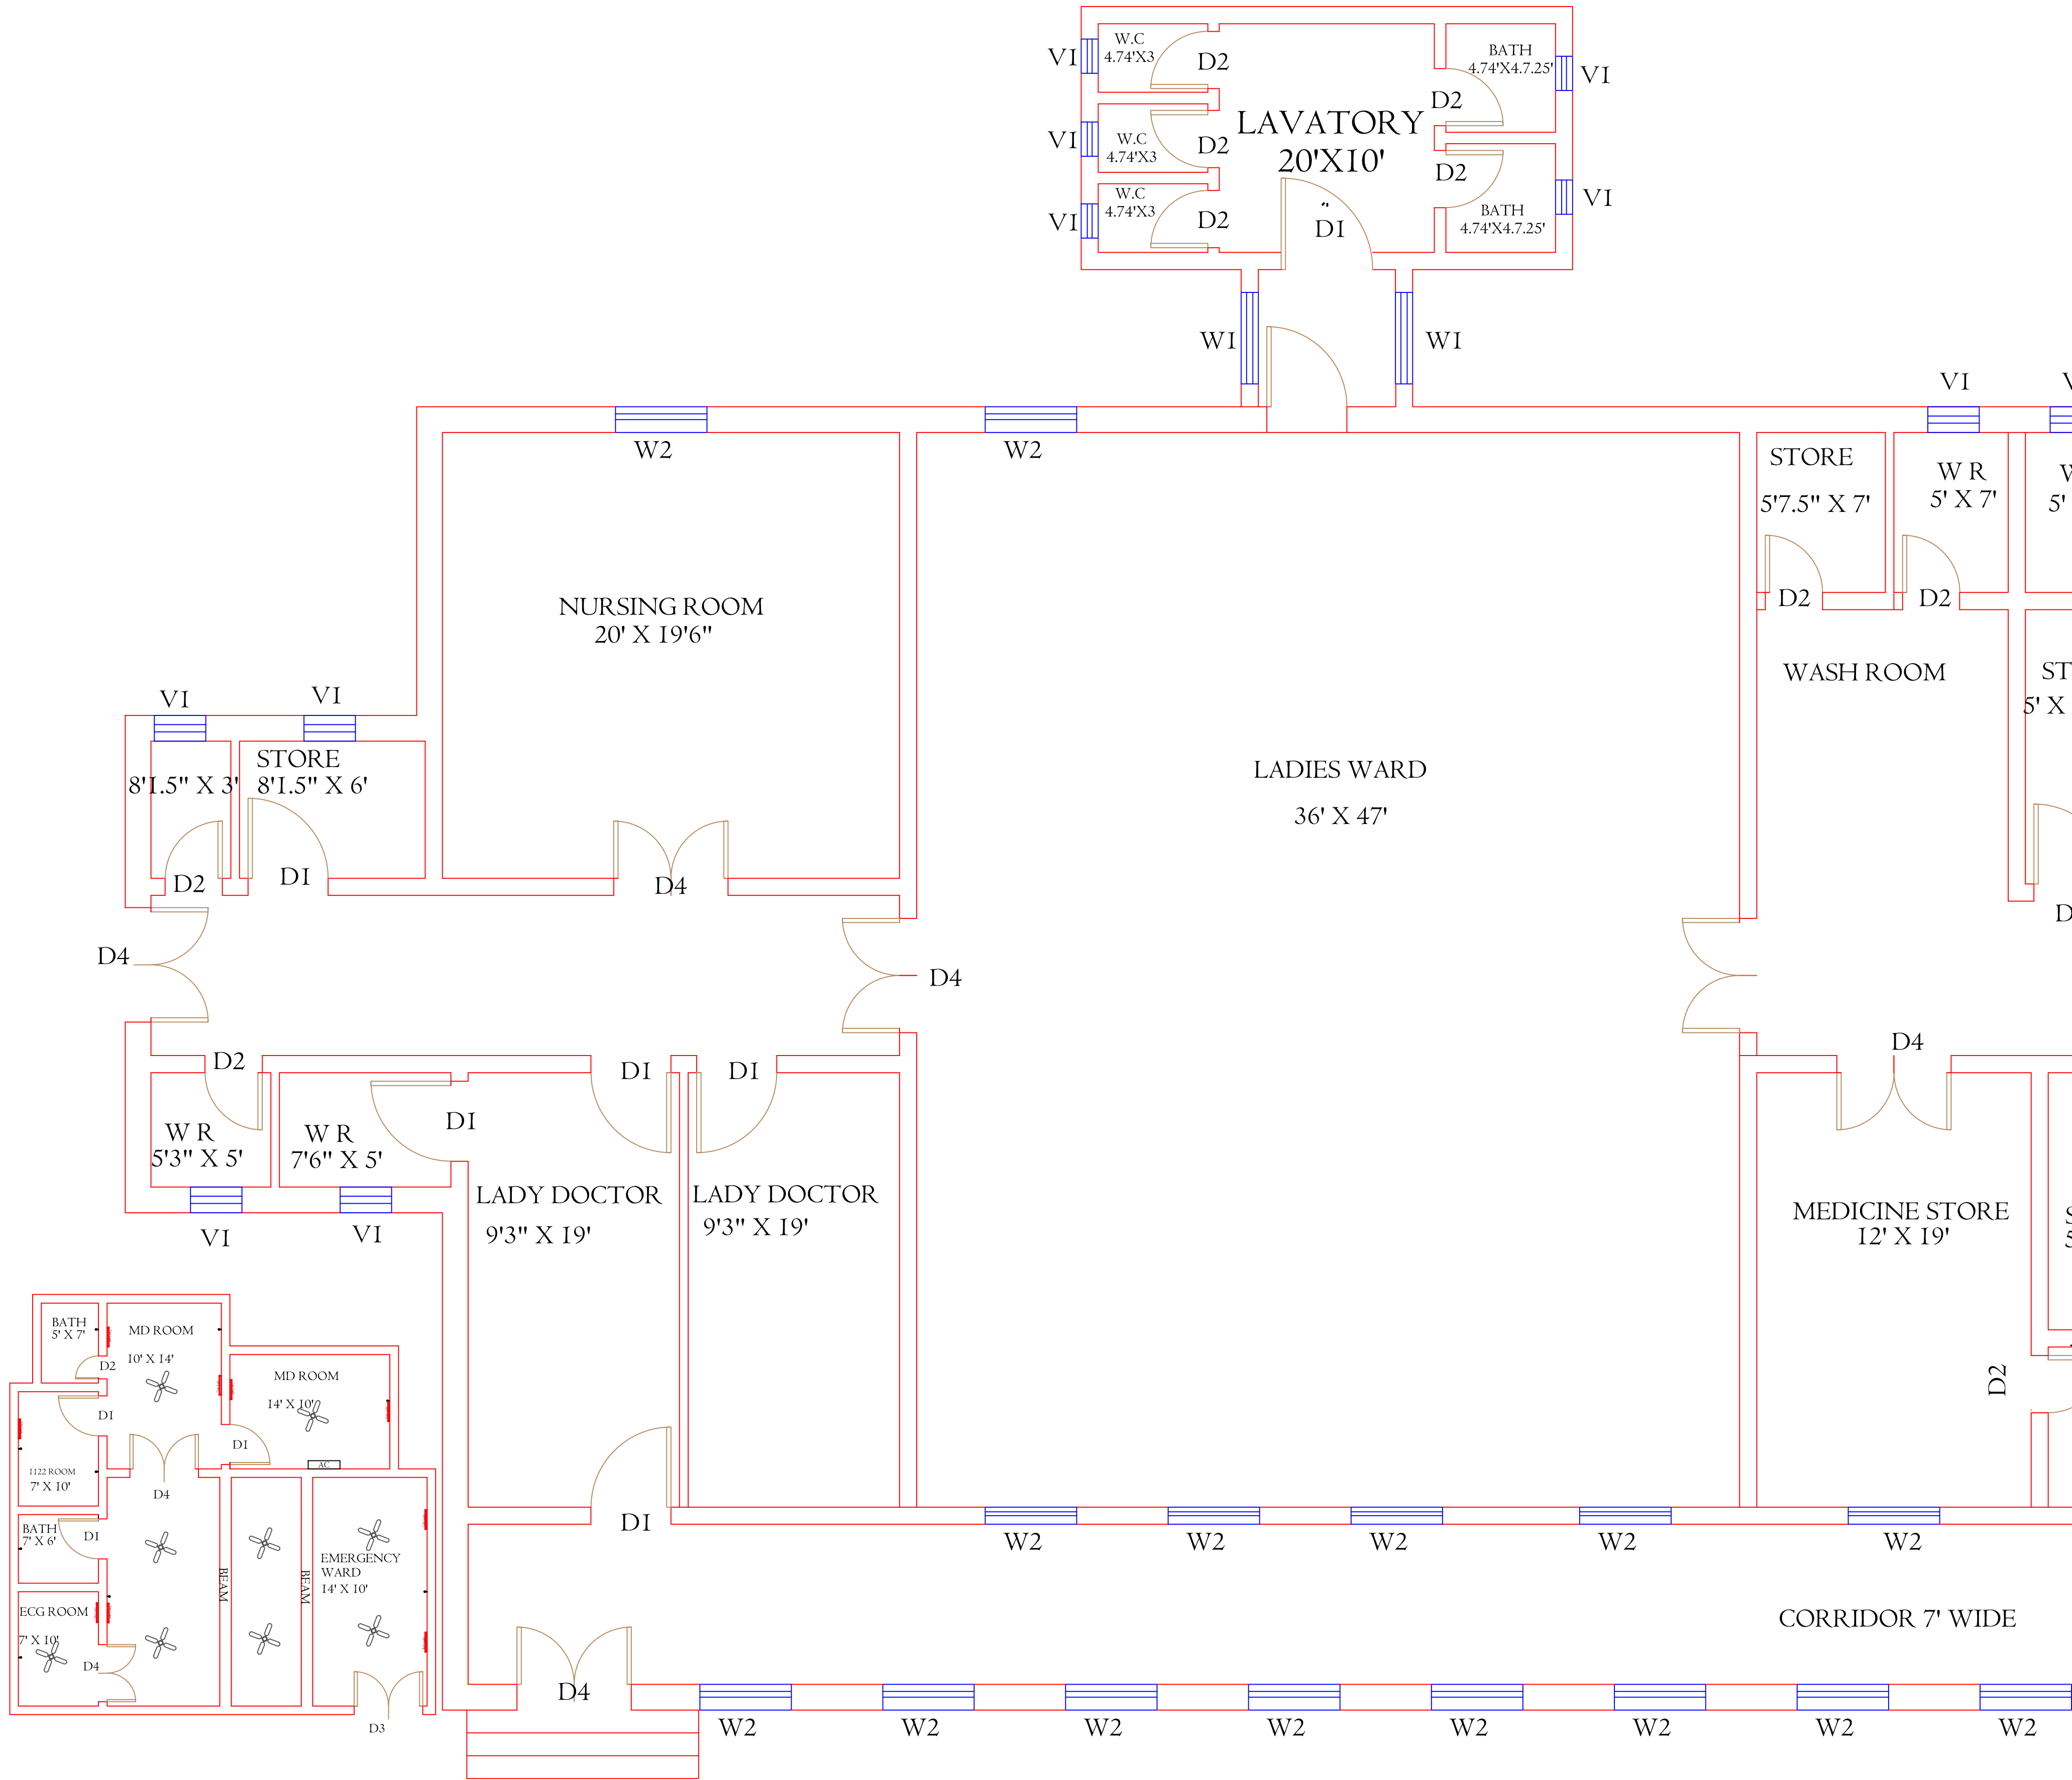

**Legends:**

Residential Area	
Road	
Wall	
Power Line	
OHT	
Tree	
ManHole	
Tube Well	
Light Pole	
Lawns	
Earthen Areas	
Asphalts Roads	
Tough Pavers	
P.C.C. /Plinth Protection	
Boundary Wall	
Tap	
Hand Pump	
BRICK Pavers	
Air Conditioner	
Tube Light	
Fan	
Roof Light	
Bulb	

AREA	
AREA WITHIN BOUNDARY WALL	483313.54Sft
AREA OF CLINICAL BLOCK	24204.00Sft
PLINTH AREA OF BLOCK	24204.00Sft

OPENING SCHEDULE OF DOORS AND WINDOWS					
DOORS	WIDTH	HEIGHT	WINDOWS	WIDTH	HEIGHT
D1	3'-6"	7'-0"	W1	4'-0"	4'-0"
D2	2'-6"	7'-0"	W2	6'-0"	6'-0"
D4	5'-0"	7'-0"	W3	2'-0"	2'-0"
D5	4'-0"	7'-0"	W4	8'-0"	8'-0"

Client:



**GOVERNMENT OF THE PUNJAB**  
**PRIMARY & SECONDARY**  
**HEALTHCARE DEPARTMENT**

Project:

**CAD MAPPING OF TEHSIL**  
**HEAD QUARTER HOSPITALS,**  
**PUNJAB**

Consultant:



**SKAFS CONSULTANT (Pvt.) Limited**  
ENGINEERING AND ENVIRONMENT CONSULTANT

Drawing Title:


**THQ MAILSI**  
**HOSPITAL CLINICAL BLOCK**  
**PART 1**

Authorized By: SKAFS	Reviewed By Co-Team Leader	Scale:
Prepared By: CAD TEAMS	Date: FEB, 2017	
Drawing No.		<b>SKAFS/MAILSI /09</b>



# CLINICAL BLOCK OF THQ HOSPITAL SHAHPUR

## GROUND FLOOR (PART 2)

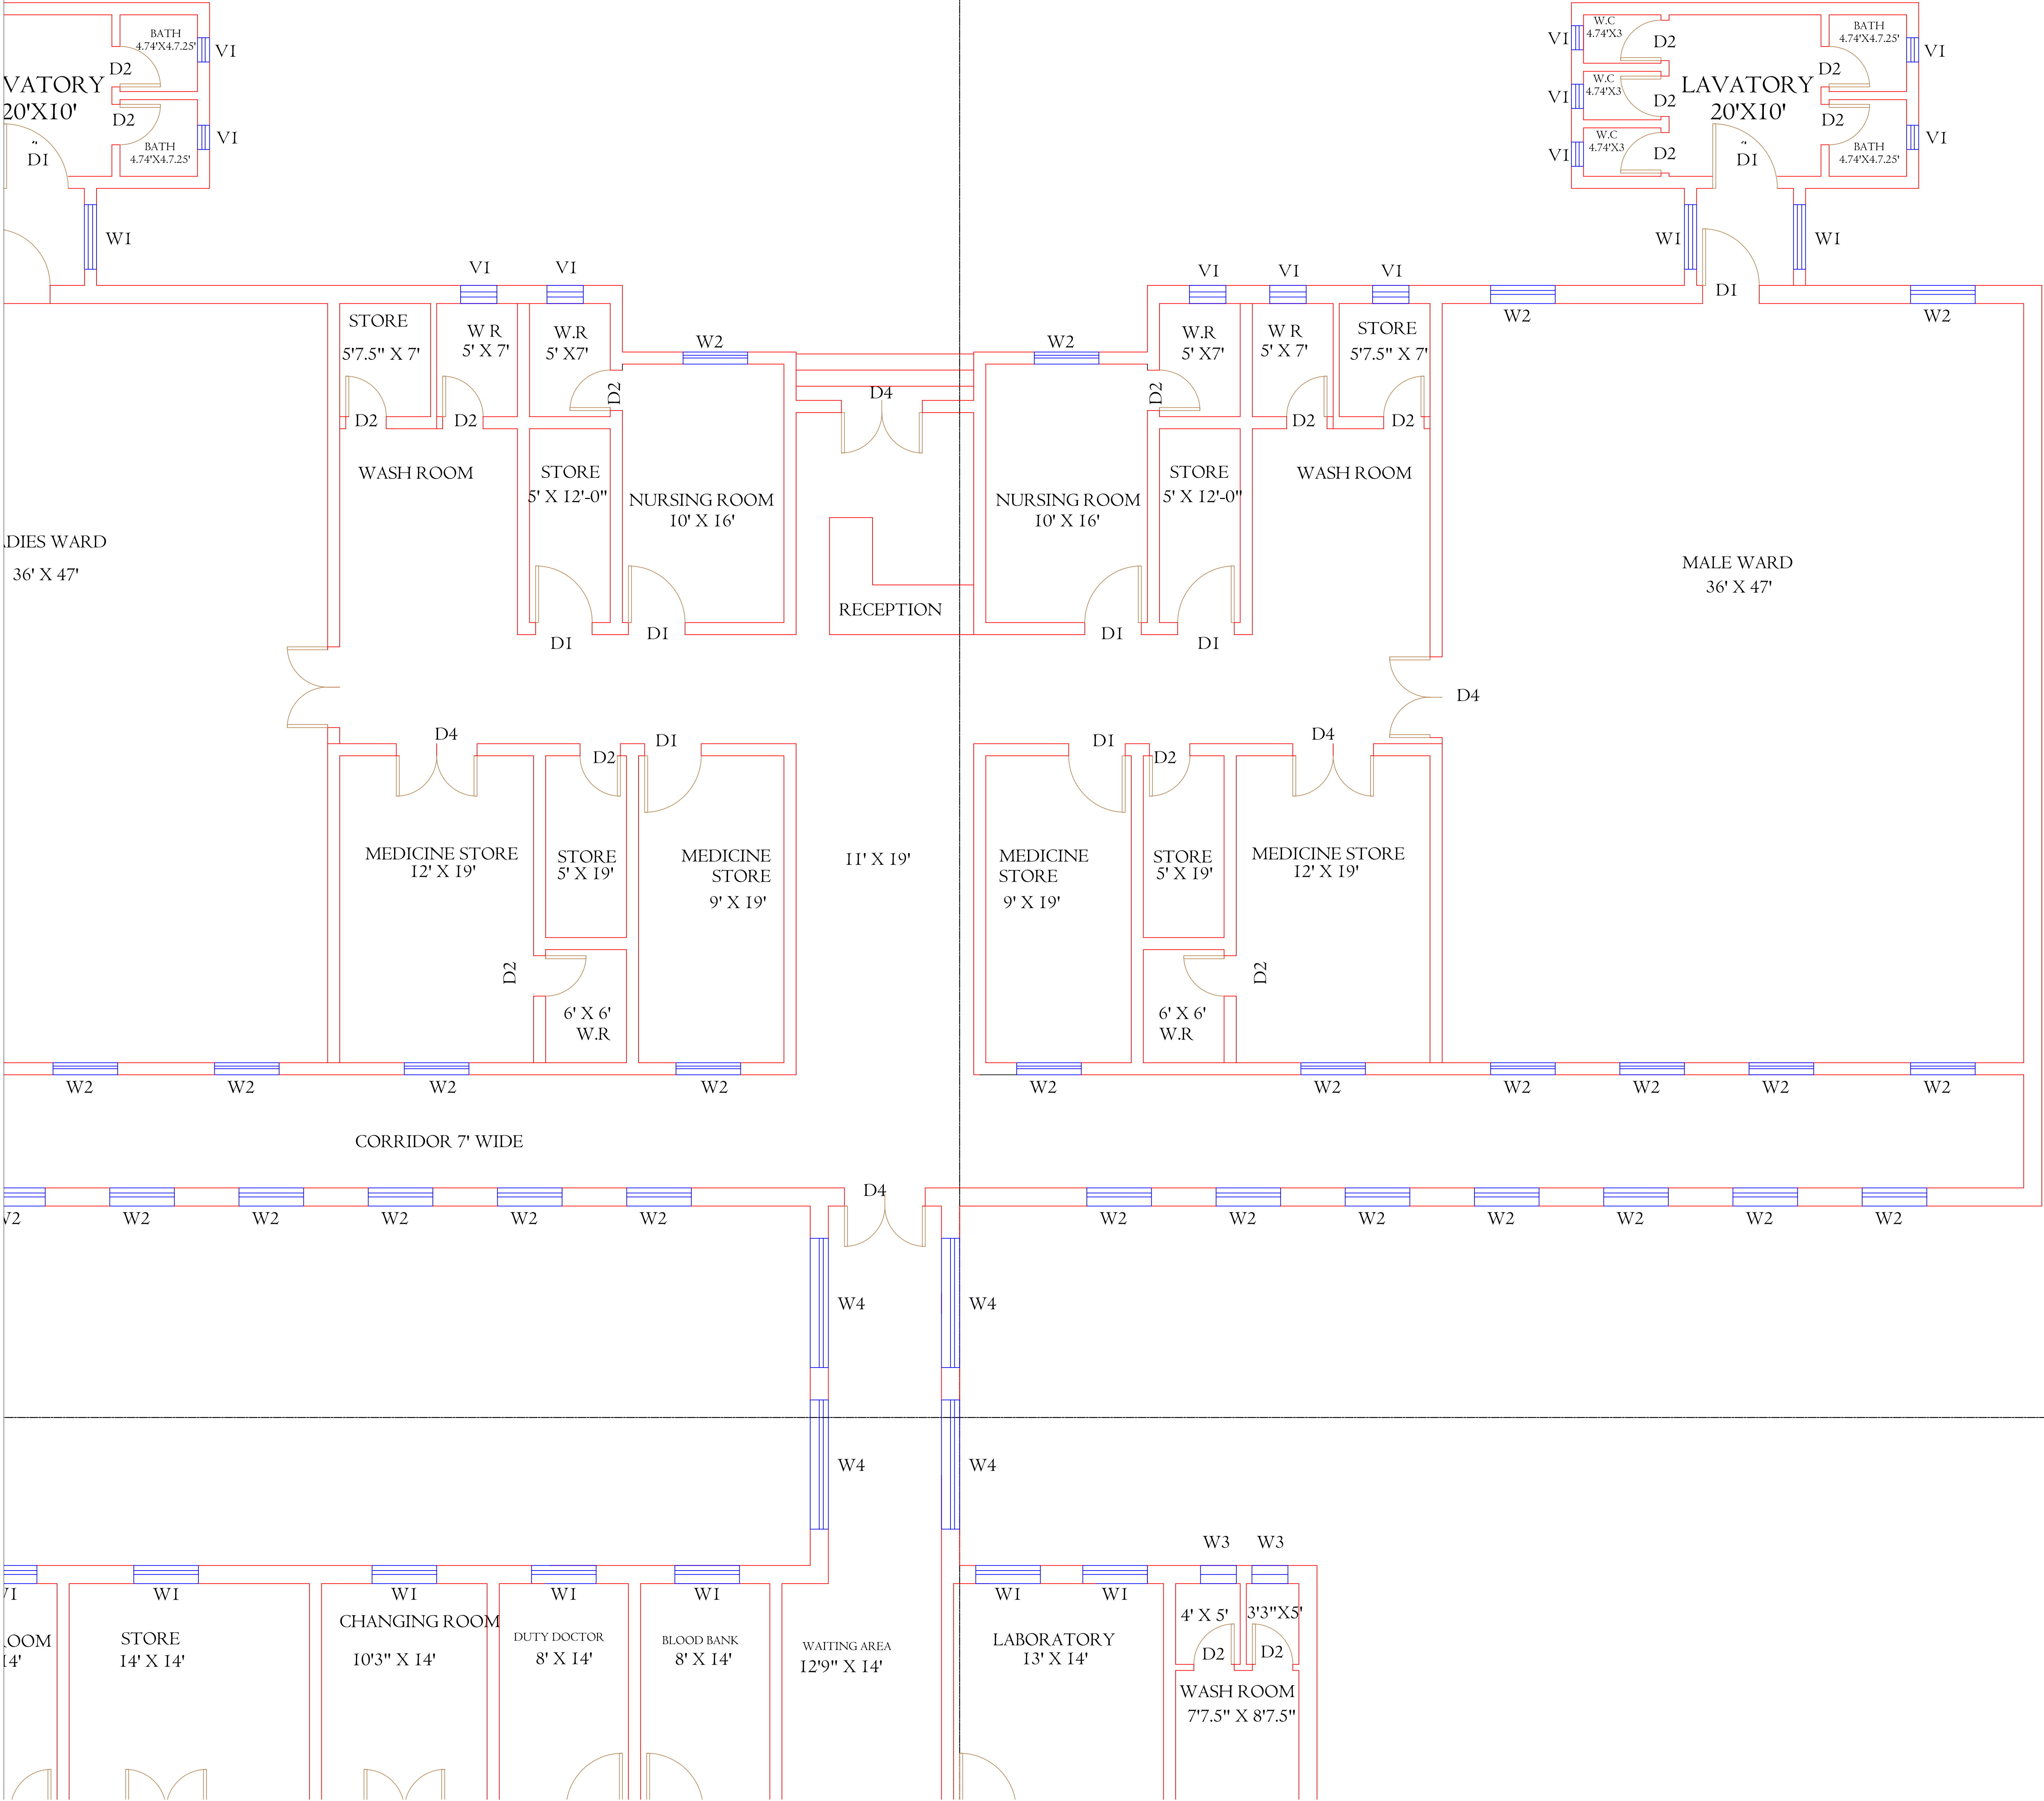

Legends:	
Residential Area	
Road	
Wall	
Power Line	
OHT	
Tree	
ManHole	
Tube Well	
Light Pole	
Lawns	
Earthen Areas	
Asphalts Roads	
Tough Pavers	
P.C.C. /Plinth Protection	
Boundary Wall	
Tap	
Hand Pump	
BRICK Pavers	
Air Conditioner	
Tube Light	
Fan	
Roof Light	
Bulb	

AREA	
AREA WITHIN BOUNDARY WALL	483313.54Sft
AREA OF CLINICAL BLOCK	24204.00Sft
PLINTH AREA OF BLOCK	24204.00Sft

OPENING SCHEDULE OF DOORS AND WINDOWS					
DOORS	WIDTH	HEIGHT	WINDOWS	WIDTH	HEIGHT
D1	3'-6"	7'-0"	W1	4'-0"	4'-0"
D2	2'-6"	7'-0"	W2	6'-0"	6'-0"
D4	5'-0"	7'-0"	W3	2'-0"	2'-0"
D5	4'-0"	7'-0"	W4	8'-0"	8'-0"

Client:

GOVERNMENT OF THE PUNJAB  
PRIMARY & SECONDARY  
HEALTHCARE DEPARTMENT

Project:

CAD MAPPING OF TEHSIL  
HEAD QUARTER HOSPITALS,  
PUNJAB

Consultant:

SKAFS CONSULTANT (Pvt.) Limited  
ENGINEERING AND ENVIRONMENT CONSULTANT


Drawing Title:




 






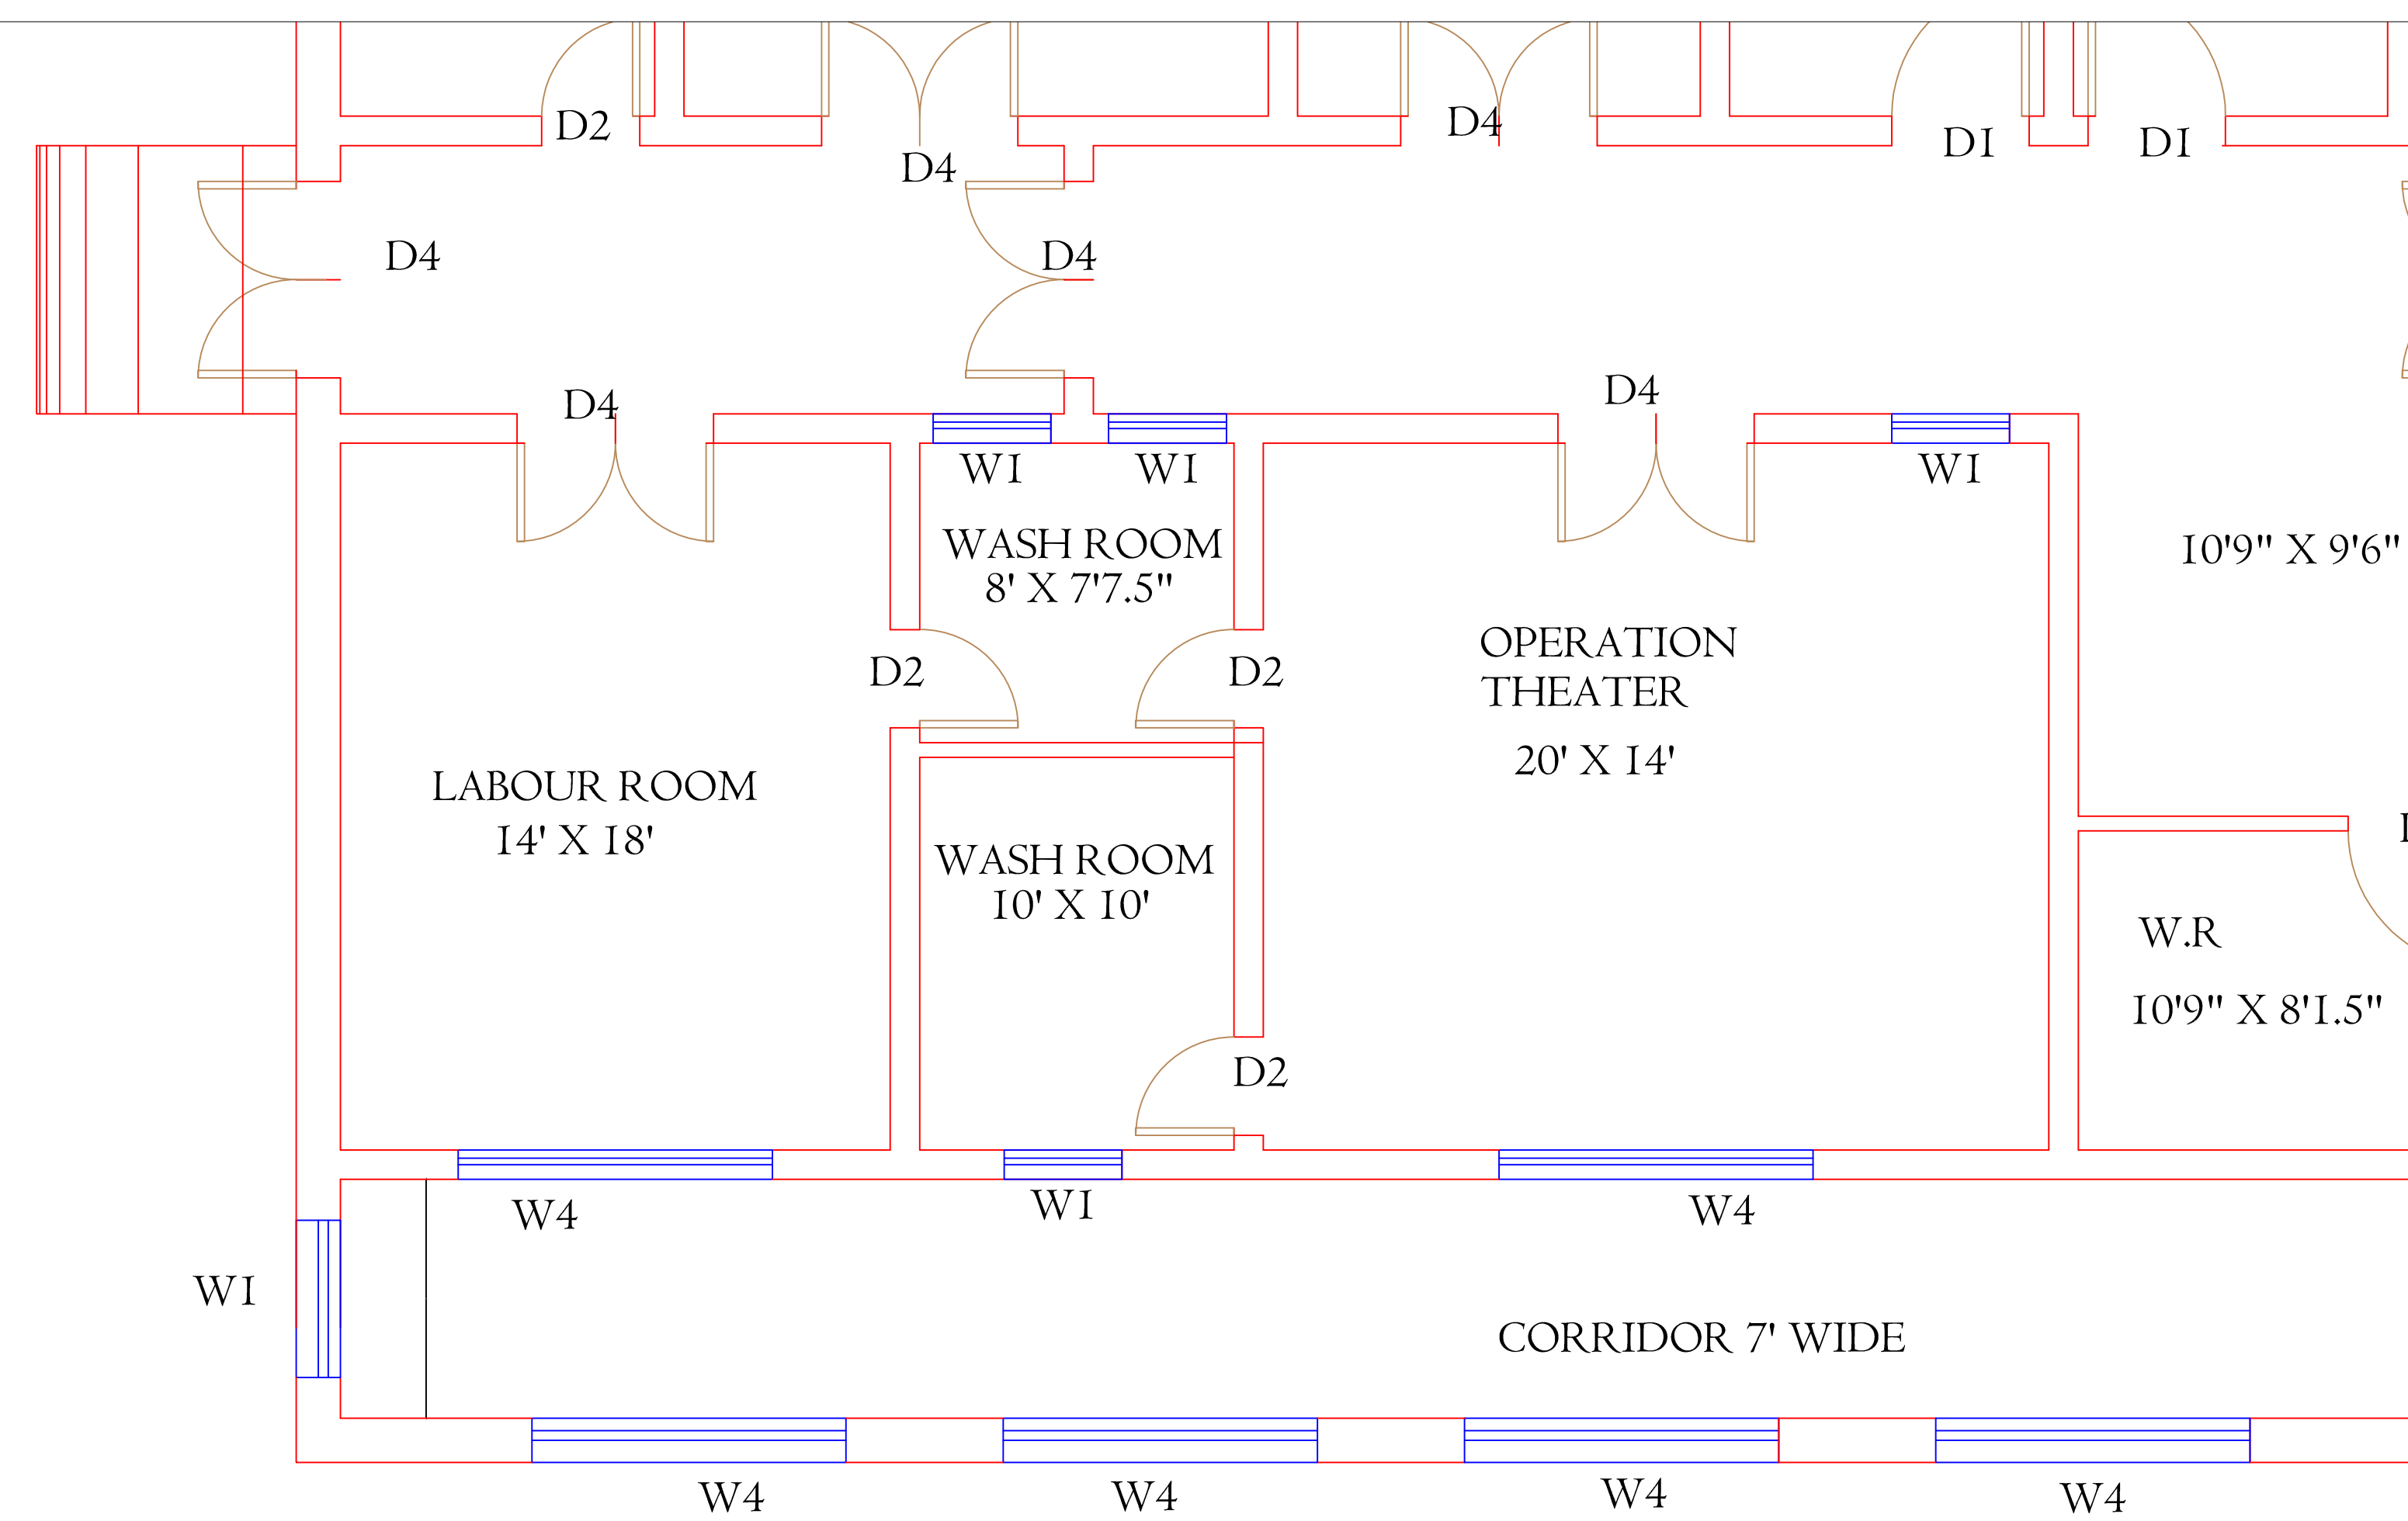


 

 



 



THQ SHAHPUR  
HOSPITAL CLINICAL BLOCK  
PART 2

Authorized By: SKAFS	Reviewed By Co-Team Leader	Scale:
Prepared By: CAD TEAMS	Date: FEB, 2017	
Drawing No.		SKAFS/SHAHPUR /10



CLINICAL BLOCK OF THQ HOSPITAL SHAHPUR  
GROUND FLOOR (PART 3)



Legends:	
Residential Area	
Road	
Wall	
Power Line	
OHT	
Tree	
ManHole	
Tube Well	
Light Pole	
Lawns	
Earthen Areas	
Asphaltes Roads	
Tough Pavers	
P.C.C. /Plinth Protection	
Boundary Wall	
Tap	
Hand Pump	
BRICK Pavers	
Air Conditioner	
Tube Light	
Fan	
Roof Light	
Bulb	

AREA	
AREA WITHIN BOUNDARY WALL	483313.54Sft
AREA OF CLINICAL BLOCK	24204.00Sft
PLINTH AREA OF BLOCK	24204.00Sft

OPENING SCHEDULE OF DOORS AND WINDOWS					
DOORS	WIDTH	HEIGHT	WINDOWS	WIDTH	HEIGHT
D1	3'-6"	7'-0"	W1	4'-0"	4'-0"
D2	2'-6"	7'-0"	W2	6'-0"	6'-0"
D4	5'-0"	7'-0"	W3	2'-0"	2'-0"
D5	4'-0"	7'-0"	W4	8'-0"	8'-0"

Client:



**GOVERNMENT OF THE PUNJAB  
PRIMARY & SECONDARY  
HEALTHCARE DEPARTMENT**

Project:

## CAD MAPPING OF TEHSIL HEAD QUARTER HOSPITALS, PUNJAB

Consultant:



**SKAFS CONSULTANT (Pvt.) Limited**  
ENGINEERING AND ENVIRONMENT CONSULTANT


Drawing Title: **THQ SHAHPUR  
HOSPITAL CLINICAL BLOCK  
PART 3**

Authorized By: SKAFS	Reviewed By Co-Team Leader	Scale:
Prepared By: CAD TEAMS	Date: FEB, 2017	
Drawing No. <b>SKAFS/SHAHPUR /11</b>		



# CLINICAL BLOCK OF THQ HOSPITAL SHAHPUR

## GROUND FLOOR (PART 4)

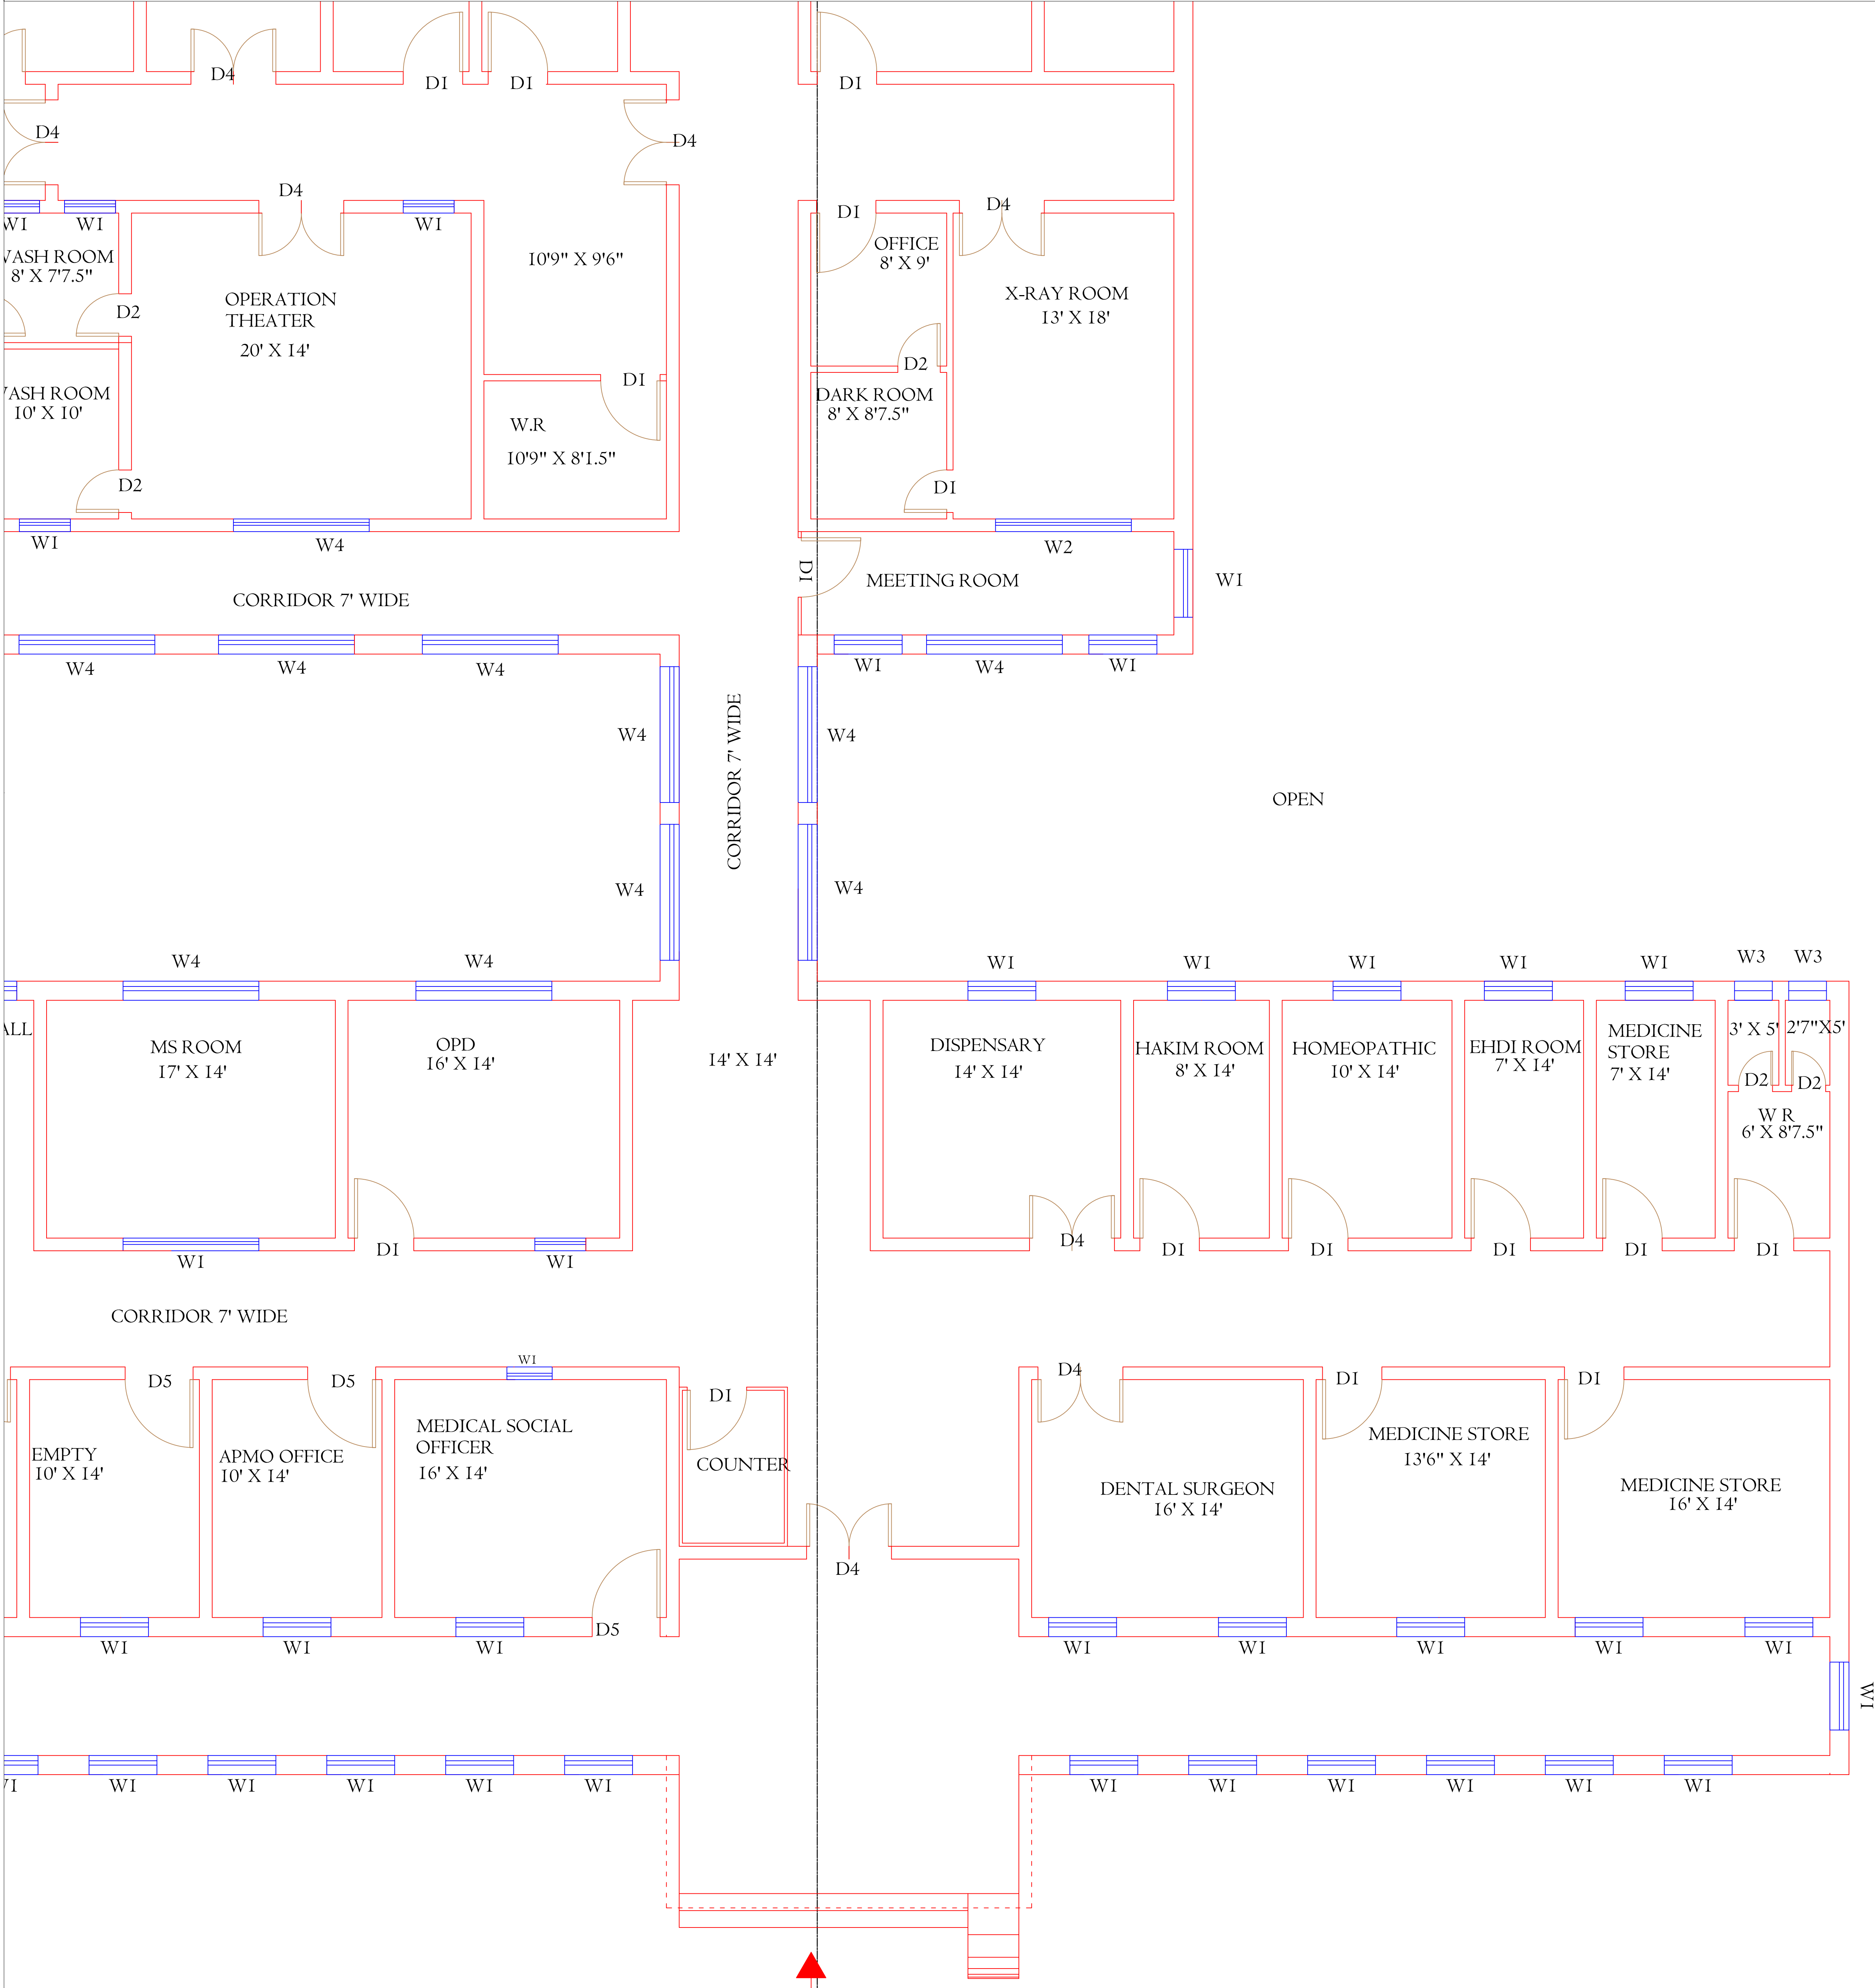

Legends:	
Residential Area	
Road	
Wall	
Power Line	
OHT	
Tree	
ManHole	
Tube Well	
Light Pole	
Lawns	
Earthen Areas	
Asphalts Roads	
Tough Pavers	
P.C.C. /Plinth Protection	
Boundary Wall	
Tap	
Hand Pump	
BRICK Pavers	
Air Conditioner	
Tube Light	
Fan	
Roof Light	
Bulb	

AREA	
AREA WITHIN BOUNDARY WALL	483313.54Sft
AREA OF CLINICAL BLOCK	24204.00Sft
PLINTH AREA OF BLOCK	24204.00Sft

OPENING SCHEDULE OF DOORS AND WINDOWS					
DOORS	WIDTH	HEIGHT	WINDOWS	WIDTH	HEIGHT
D1	3'-6"	7'-0"	W1	4'-0"	4'-0"
D2	2'-6"	7'-0"	W2	6'-0"	6'-0"
D4	5'-0"	7'-0"	W3	2'-0"	2'-0"
D5	4'-0"	7'-0"	W4	8'-0"	8'-0"

Client:



**GOVERNMENT OF THE PUNJAB**  
**PRIMARY & SECONDARY**  
**HEALTHCARE DEPARTMENT**

Project:

**CAD MAPPING OF TEHSIL**  
**HEAD QUARTER HOSPITALS,**  
**PUNJAB**

Consultant:



**SKAFS CONSULTANT (Pvt.) Limited**  
ENGINEERING AND ENVIRONMENT CONSULTANT

Drawing Title:


**THQ SHAHPUR**  
**HOSPITAL CLINICAL BLOCK**  
**PART 4**

Authorized By: SKAFS	Reviewed By Co-Team Leader	Scale:
Prepared By: CAD TEAMS	Date: FEB, 2017	



# ELECTRICAL LAYOUT PLAN OF THQ HOSPITAL SHAHPUR

## GROUND FLOOR

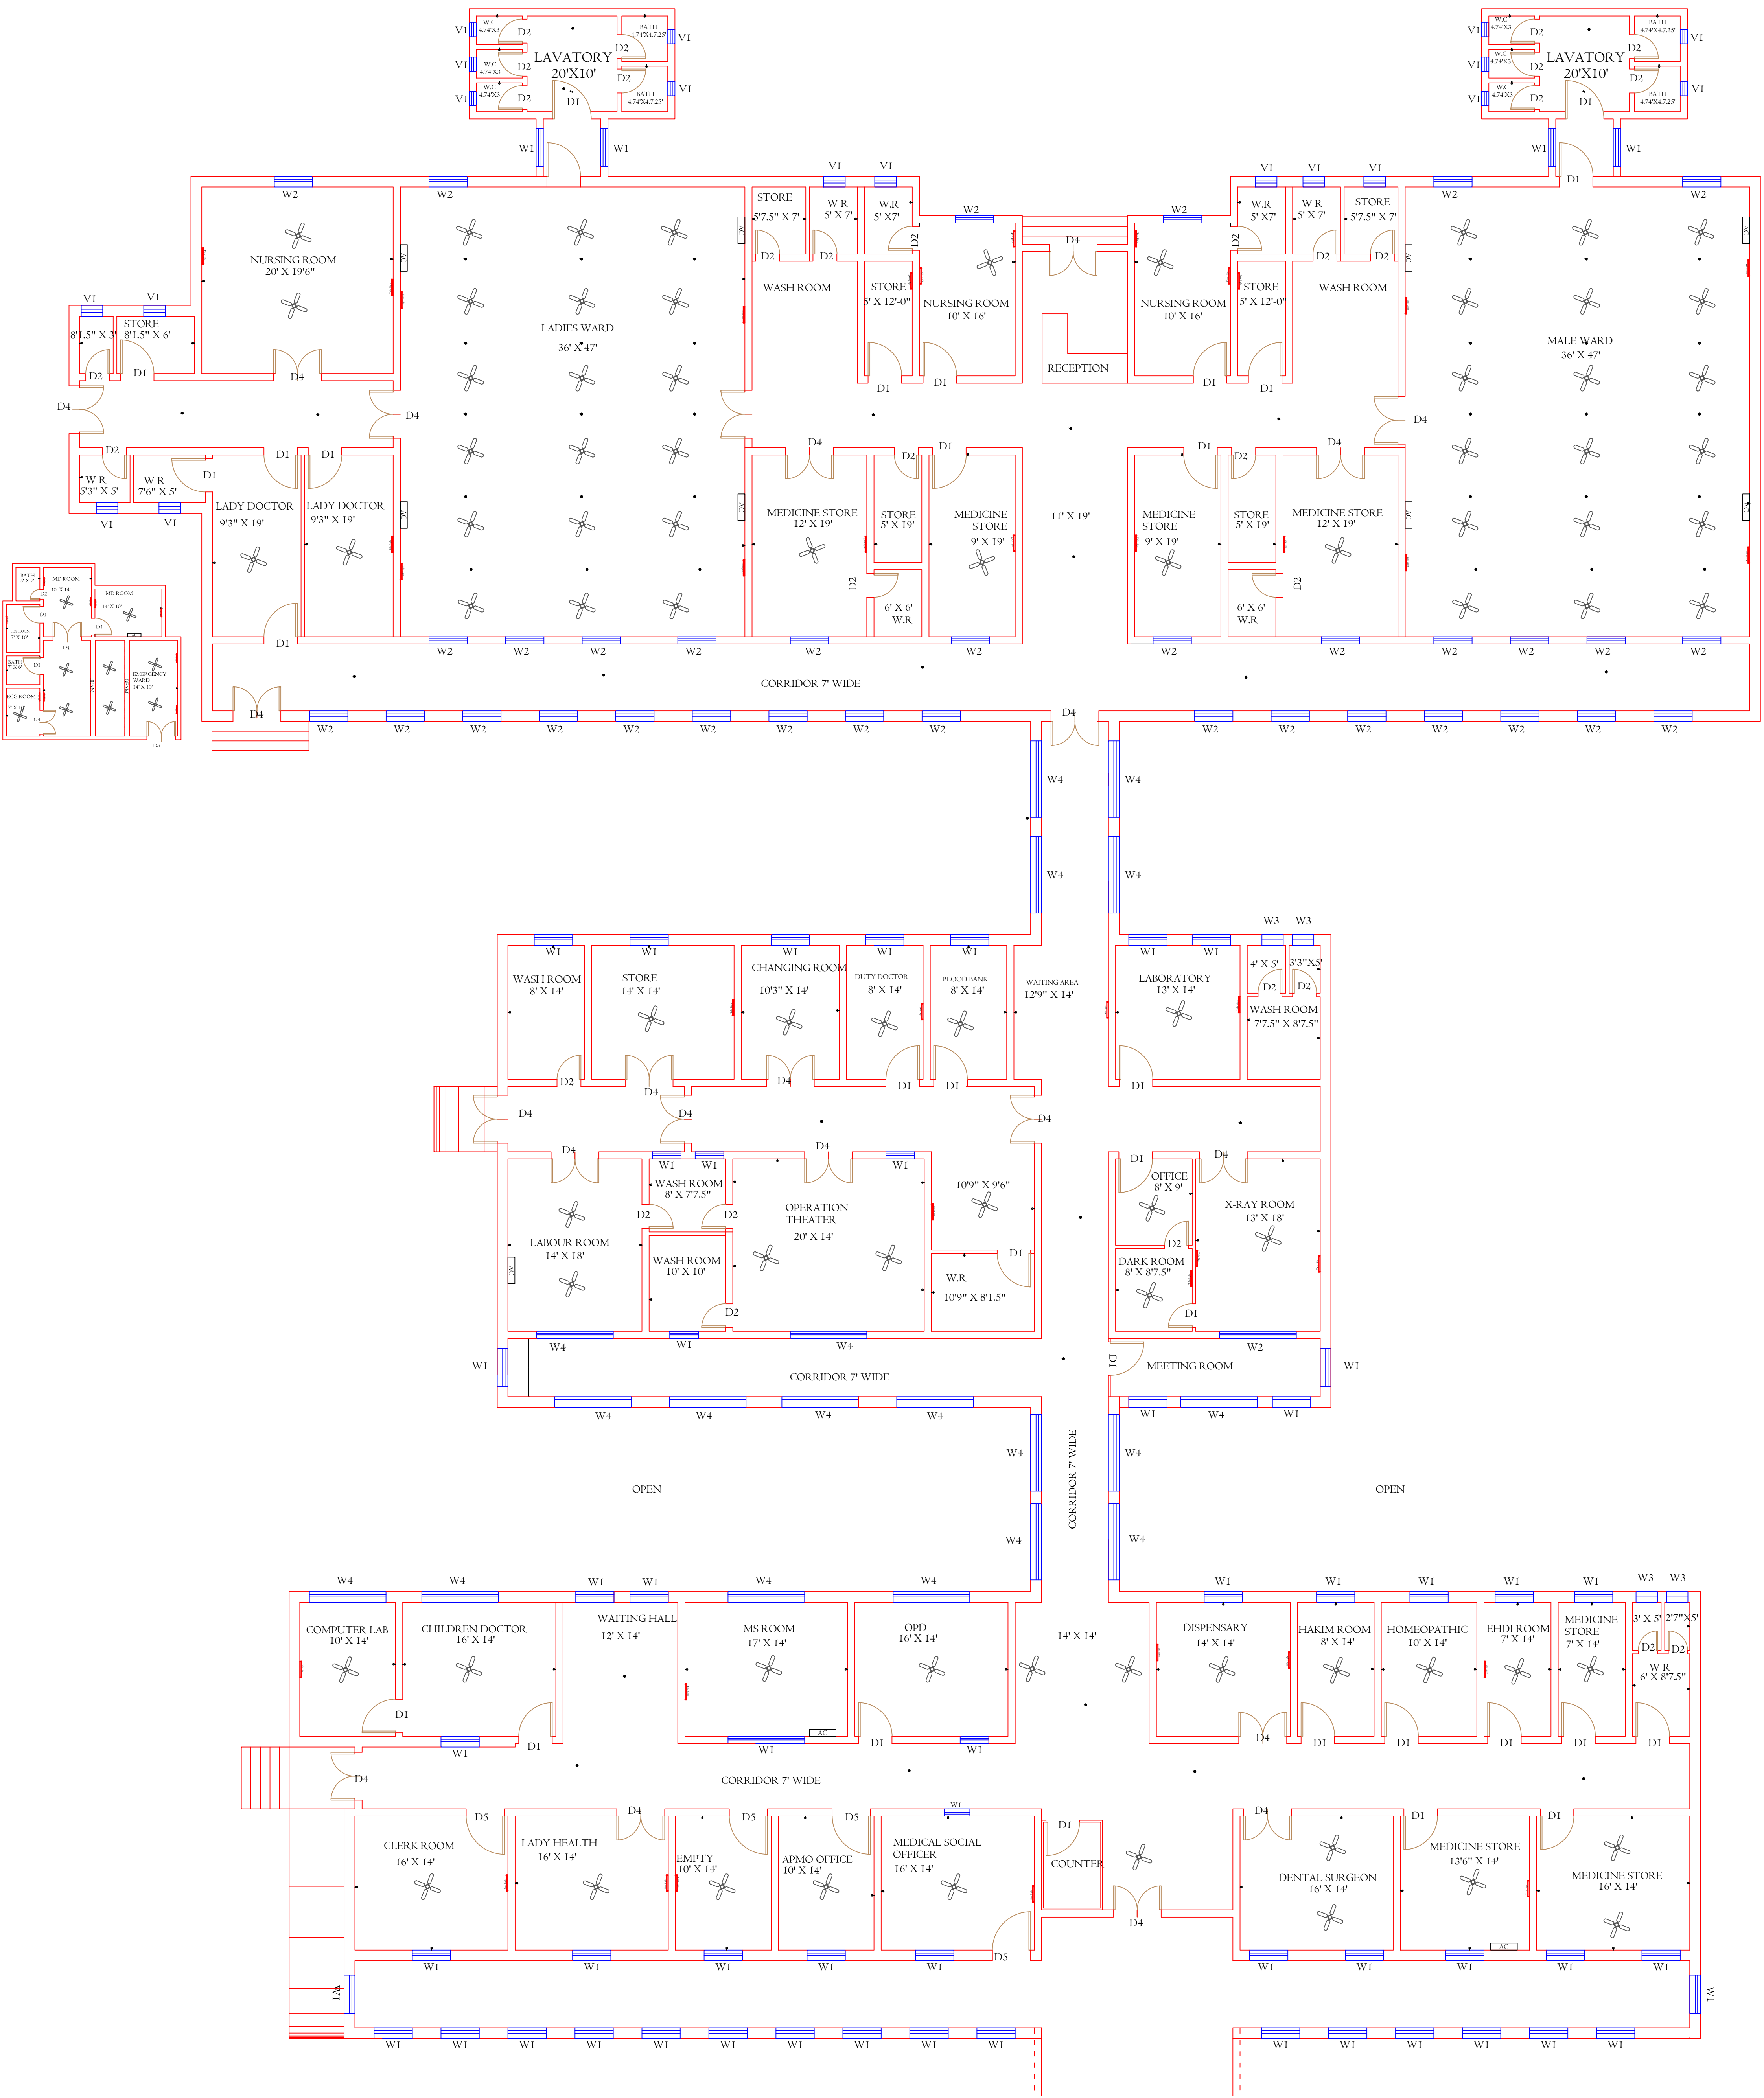

Legends:

Residential Area	
Road	
Wall	
Power Line	
OHT	
Tree	
ManHole	
Tube Well	
Light Pole	
Lawns	
Earthen Areas	
Asphalts Roads	
Tough Pavers	
P.C.C. /Plinth Protection	
Boundary Wall	
Tap	
Hand Pump	
BRICK Pavers	
Air Conditioner	
Tube Light	
Fan	
Roof Light	
Bulb	

AREA	
AREA WITHIN BOUNDARY WALL	483313.54Sft
AREA OF CLINICAL BLOCK	24204.00Sft
PLINTH AREA OF BLOCK	24204.00Sft

OPENING SCHEDULE OF DOORS AND WINDOWS					
DOORS	WIDTH	HEIGHT	WINDOWS	WIDTH	HEIGHT
D1	3'-6"	7'-0"	W1	4'-0"	4'-0"
D2	2'-6"	7'-0"	W2	6'-0"	6'-0"
D4	5'-0"	7'-0"	W3	2'-0"	2'-0"
D5	4'-0"	7'-0"	W4	8'-0"	8'-0"

Client:



GOVERNMENT OF THE PUNJAB  
PRIMARY & SECONDARY  
HEALTHCARE DEPARTMENT

Project:

CAD MAPPING OF TEHSIL  
HEAD QUARTER HOSPITALS,  
PUNJAB

Consultant:



SKAFS CONSULTANT (Pvt.) Limited  
ENGINEERING AND ENVIRONMENT CONSULTANT

Drawing Title:

THQ SHAHPUR  
ELECTRICAL LAYOUT  
GROUND FLOOR

Authorized By: SKAFS	Reviewed By Co-Team Leader	Scale:
Prepared By: CAD TEAMS	Date: FEB, 2017	
Drawing No.		SKAFS/SHAHPUR /13