

MASTER PLAN OF THQ HOSPITAL SHORKOT

PART 1

PART 2

PART 3

PART 4



Legends:

Residential Area	
Road	
Wall	
Power Line	
OHT	
Tree	
Man Hole	
Tube Well	
Light Pole	
Lawns	
Earthen Areas	
Asphalts Roads	
Tough Pavers	
P.C.C / Plinth Protection	
Boundary Wall	
Brick Pavers / Soling	
Drain	
Tap	
Hand Pump	
Air Conditioner	
Tube Light	
Fan	
Roof Light	
Bulb	

AREA	
AREA WITHIN BOUNDARY WALL	347041.43 Sft
AREA OF CLINICAL BLOCK	39148.43 Sft
PLINTH AREA OF BLOCK	36413.22 Sft

OPENING SCHEDULE OF DOORS AND WINDOWS					
DOORS	WIDTH	HEIGHT	WINDOWS	WIDTH	HEIGHT
D1	5'-6"	7'-0"	W0	2'-0"	2'-0"
D2	5'-0"	7'-0"	W1	3'-0"	3'-0"
D3	4'-0"	7'-0"	W2	4'-0"	4'-0"
D4	3'-6"	7'-0"	W2.1	5'-0"	5'-0"
D5	3'-0"	7'-0"	W3	6'-0"	6'-0"
D6	2'-6"	7'-0"	W4	7'-0"	7'-0"
D7	6'-0"	7'-0"	W5	8'-0"	8'-0"
V1	2'-0"	2'-0"	W6	9'-0"	9'-0"
			W6.1	10'-0"	10'-0"

Project:
CAD MAPPING OF TEHSIL HEAD QUARTER HOSPITALS, PUNJAB

Client: GOVERNMENT OF THE PUNJAB PRIMARY & SECONDARY HEALTHCARE DEPARTMENT	Consultant: SKAFS CONSULTANT (Pvt.) Limited ENGINEERING AND ENVIRONMENT CONSULTANT
---	--

Drawing Title:
THQ SHORKOT HOSPITAL MASTER PLAN

Drawing No. **SKAFS/SHORKOT /03**

MASTER PLAN OF THQ HOSPITAL SHORKOT

PART 1



Legends:

Residential Area	
Road	
Wall	
Power Line	
OHT	
Tree	
Man Hole	
Tube Well	
Light Pole	
Lawns	
Earthen Areas	
Asphalts Roads	
Tough Pavers	
P.C.C / Plinth Protection	
Boundary Wall	
Brick Pavers / Soling	
Drain	
Tap	
Hand Pump	
Air Conditioner	
Tube Light	
Fan	
Roof Light	
Bulb	

AREA	
AREA WITHIN BOUNDARY WALL	347041.43 Sft
AREA OF CLINICAL BLOCK	39148.43 Sft
PLINTH AREA OF BLOCK	36413.22 Sft

OPENING SCHEDULE OF DOORS AND WINDOWS					
DOORS	WIDTH	HEIGHT	WINDOWS	WIDTH	HEIGHT
D1	5'-6"	7'-0"	W0	2'-0"	2'-0"
D2	5'-0"	7'-0"	W1	3'-0"	3'-0"
D3	4'-0"	7'-0"	W2	4'-0"	4'-0"
D4	3'-6"	7'-0"	W2.1	5'-0"	5'-0"
D5	3'-0"	7'-0"	W3	6'-0"	6'-0"
D6	2'-6"	7'-0"	W4	7'-0"	7'-0"
D7	6'-0"	7'-0"	W5	8'-0"	8'-0"
V1	2'-0"	2'-0"	W6	9'-0"	9'-0"
			W6.1	10'-0"	10'-0"

Project:
CAD MAPPING OF TEHSIL HEAD QUARTER HOSPITALS, PUNJAB

Client: GOVERNMENT OF THE PUNJAB PRIMARY & SECONDARY HEALTHCARE DEPARTMENT	Consultant: SKAFS CONSULTANT (Pvt.) Limited ENGINEERING AND ENVIRONMENT CONSULTANT
---	--

Drawing Title:
THQ SHORKOT HOSPITAL MASTER PLAN PART 1

Drawing No. SKAFS/SHORKOT /04

MASTER PLAN OF THQ HOSPITAL SHORKOT

PART 2



Legends:

Residential Area	
Road	
Wall	
Power Line	
OHT	
Tree	
Man Hole	
Tube Well	
Light Pole	
Lawns	
Earthen Areas	
Asphalts Roads	
Tough Pavers	
P.C.C / Plinth Protection	
Boundary Wall	
Brick Pavers / Soling	
Drain	
Tap	
Hand Pump	
Air Conditioner	
Tube Light	
Fan	
Roof Light	
Bulb	

AREA	
AREA WITHIN BOUNDARY WALL	347041.43 Sft
AREA OF CLINICAL BLOCK	39148.43 Sft
PLINTH AREA OF BLOCK	36413.22 Sft

OPENING SCHEDULE OF DOORS AND WINDOWS					
DOORS	WIDTH	HEIGHT	WINDOWS	WIDTH	HEIGHT
D1	5'-6"	7'-0"	W0	2'-0"	2'-0"
D2	5'-0"	7'-0"	W1	3'-0"	3'-0"
D3	4'-0"	7'-0"	W2	4'-0"	4'-0"
D4	3'-6"	7'-0"	W2.1	5'-0"	5'-0"
D5	3'-0"	7'-0"	W3	6'-0"	6'-0"
D6	2'-6"	7'-0"	W4	7'-0"	7'-0"
D7	6'-0"	7'-0"	W5	8'-0"	8'-0"
V1	2'-0"	2'-0"	W6	9'-0"	9'-0"
			W6.1	10'-0"	10'-0"

Project:
CAD MAPPING OF TEHSIL HEAD QUARTER HOSPITALS, PUNJAB

Client: GOVERNMENT OF THE PUNJAB PRIMARY & SECONDARY HEALTHCARE DEPARTMENT	Consultant: SKAFS CONSULTANT (Pvt.) Limited ENGINEERING AND ENVIRONMENT CONSULTANT
---	--

Drawing Title:
THQ SHORKOT HOSPITAL MASTER PLAN PART 2

Drawing No. **SKAFS/SHORKOT /05**

MASTER PLAN OF THQ HOSPITAL SHORKOT

PART 3



Legends:

Residential Area	
Road	
Wall	
Power Line	
OHT	
Tree	
Man Hole	
Tube Well	
Light Pole	
Lawns	
Earthen Areas	
Asphalts Roads	
Tough Pavers	
P.C.C / Plinth Protection	
Boundary Wall	
Brick Pavers / Soling	
Drain	
Tap	
Hand Pump	
Air Conditioner	
Tube Light	
Fan	
Roof Light	
Bulb	

AREA	
AREA WITHIN BOUNDARY WALL	347041.43 Sft
AREA OF CLINICAL BLOCK	39148.43 Sft
PLINTH AREA OF BLOCK	36413.22 Sft

OPENING SCHEDULE OF DOORS AND WINDOWS					
DOORS	WIDTH	HEIGHT	WINDOWS	WIDTH	HEIGHT
D1	5'-6"	7'-0"	W0	2'-0"	2'-0"
D2	5'-0"	7'-0"	W1	3'-0"	3'-0"
D3	4'-0"	7'-0"	W2	4'-0"	4'-0"
D4	3'-6"	7'-0"	W2.1	5'-0"	5'-0"
D5	3'-0"	7'-0"	W3	6'-0"	6'-0"
D6	2'-6"	7'-0"	W4	7'-0"	7'-0"
D7	6'-0"	7'-0"	W5	8'-0"	8'-0"
V1	2'-0"	2'-0"	W6	9'-0"	9'-0"
			W6.1	10'-0"	10'-0"

Project:
CAD MAPPING OF TEHSIL HEAD QUARTER HOSPITALS, PUNJAB


Client: GOVERNMENT OF THE PUNJAB PRIMARY & SECONDARY HEALTHCARE DEPARTMENT	Consultant: SKAFS CONSULTANT (Pvt.) Limited ENGINEERING AND ENVIRONMENT CONSULTANT
---	--

Drawing Title:
THQ SHORKOT HOSPITAL MASTER PLAN PART 3

Drawing No. **SKAFS/SHORKOT /06**

MASTER PLAN OF THQ HOSPITAL SHORKOT

PART 4

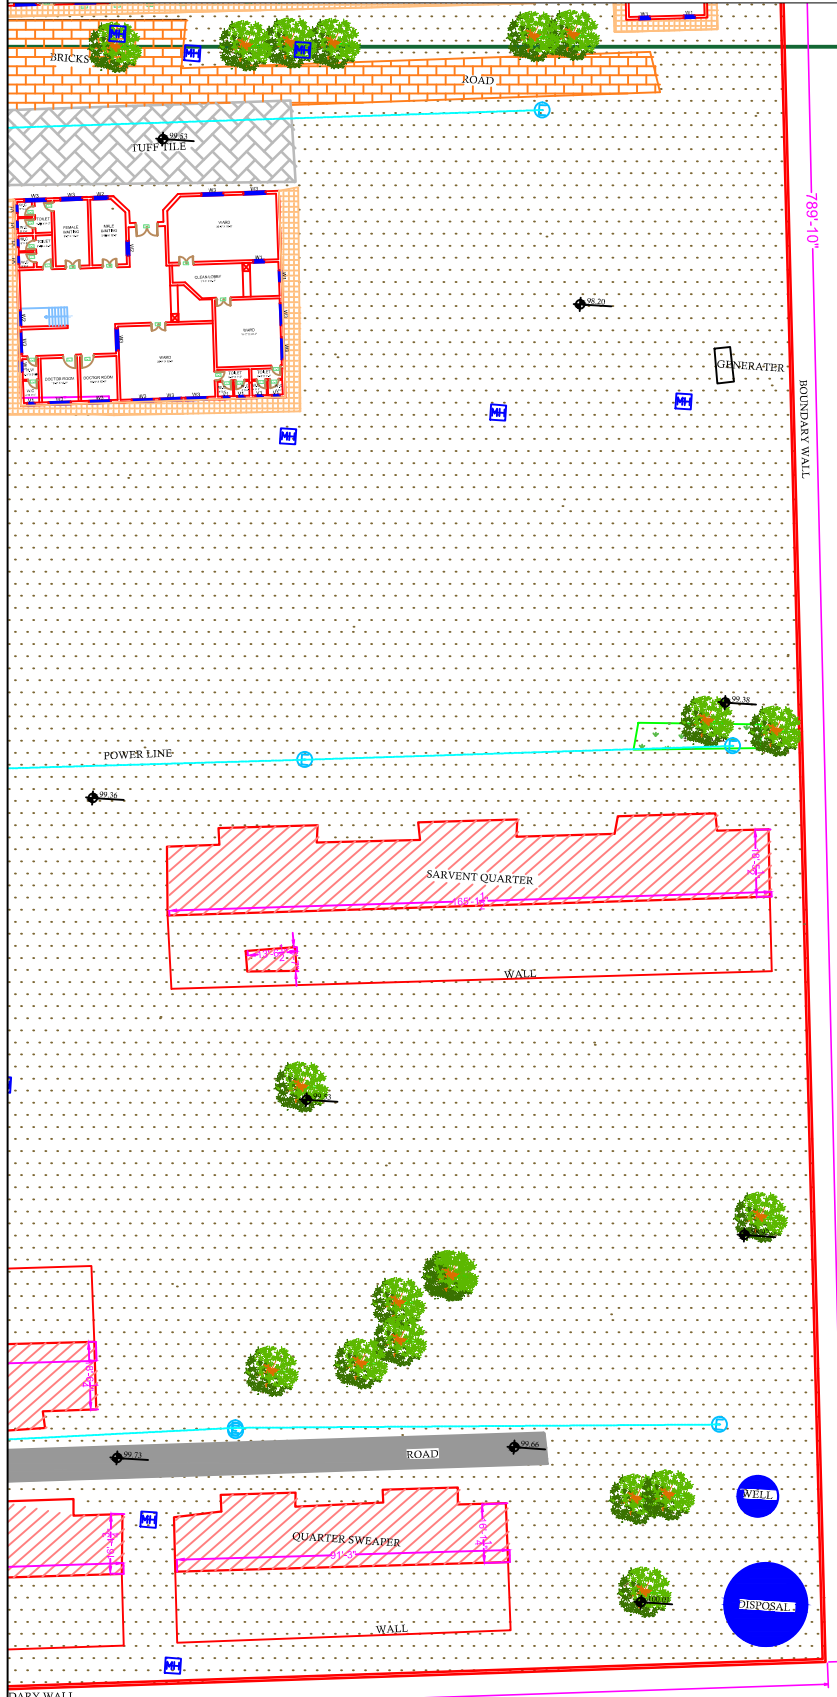

Legends:

Residential Area	
Road	
Wall	
Power Line	
OHT	
Tree	
Man Hole	
Tube Well	
Light Pole	
Lawns	
Earthen Areas	
Asphalts Roads	
Tough Pavers	
P.C.C / Plinth Protection	
Boundary Wall	
Brick Pavers / Soling	
Drain	
Tap	
Hand Pump	
Air Conditioner	
Tube Light	
Fan	
Roof Light	
Bulb	

AREA	
AREA WITHIN BOUNDARY WALL	347041.43 Sft
AREA OF CLINICAL BLOCK	39148.43 Sft
PLINTH AREA OF BLOCK	36413.22 Sft

OPENING SCHEDULE OF DOORS AND WINDOWS					
DOORS	WIDTH	HEIGHT	WINDOWS	WIDTH	HEIGHT
D1	5'-6"	7'-0"	W0	2'-0"	2'-0"
D2	5'-0"	7'-0"	W1	3'-0"	3'-0"
D3	4'-0"	7'-0"	W2	4'-0"	4'-0"
D4	3'-6"	7'-0"	W2.1	5'-0"	5'-0"
D5	3'-0"	7'-0"	W3	6'-0"	6'-0"
D6	2'-6"	7'-0"	W4	7'-0"	7'-0"
D7	6'-0"	7'-0"	W5	8'-0"	8'-0"
V1	2'-0"	2'-0"	W6	9'-0"	9'-0"
			W6.1	10'-0"	10'-0"

Project:
CAD MAPPING OF TEHSIL HEAD QUARTER HOSPITALS, PUNJAB


Client: GOVERNMENT OF THE PUNJAB PRIMARY & SECONDARY HEALTHCARE DEPARTMENT	Consultant: SKAFS CONSULTANT (Pvt.) Limited ENGINEERING AND ENVIRONMENT CONSULTANT
---	--

Drawing Title:
THQ SHORKOT HOSPITAL MASTER PLAN PART 4

Drawing No. **SKAFS/SHORKOT /07**











CLINICAL BLOCK OF THQ HOSPITAL SHORKOT

GROUND FLOOR



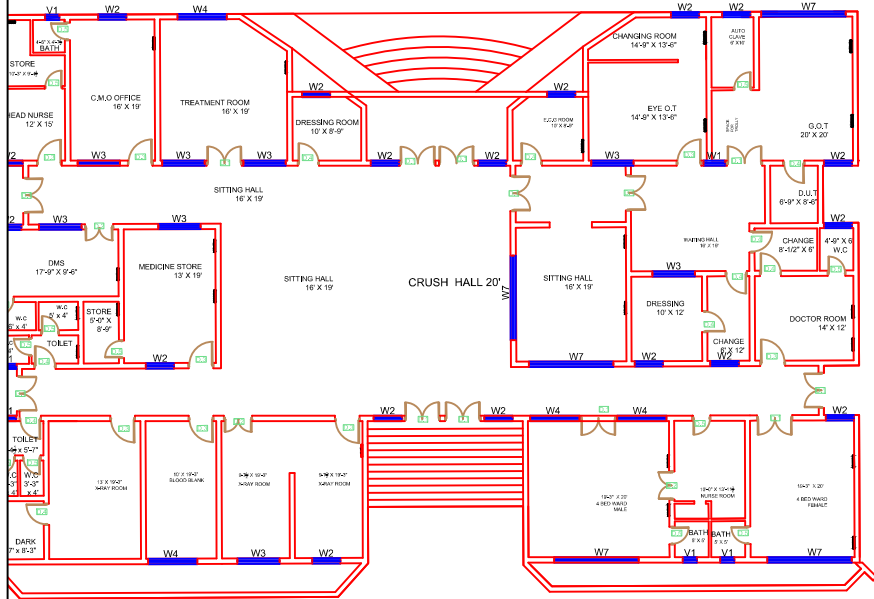


PART 1

 PART 3

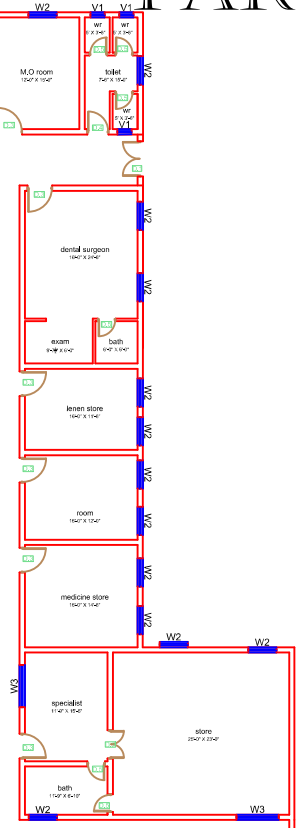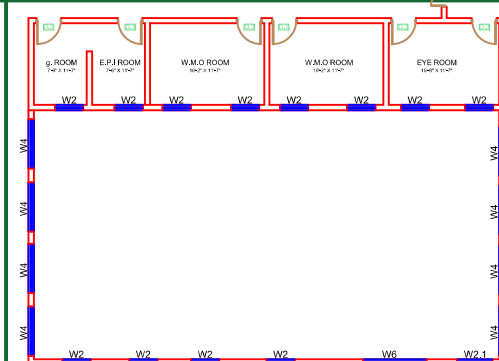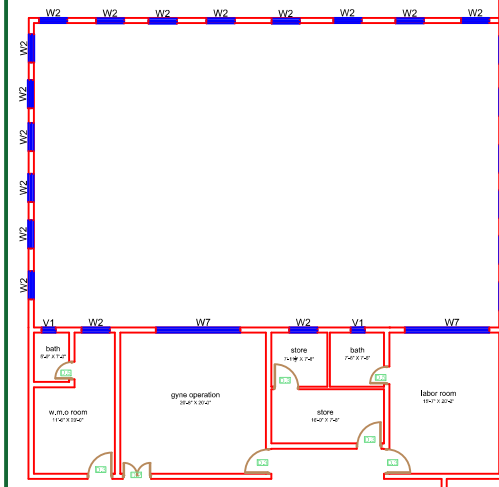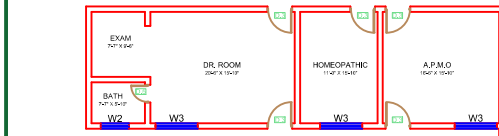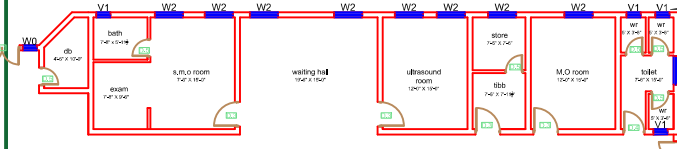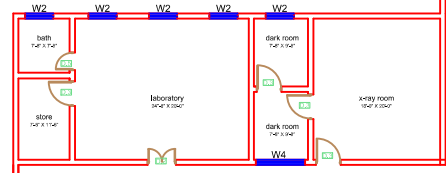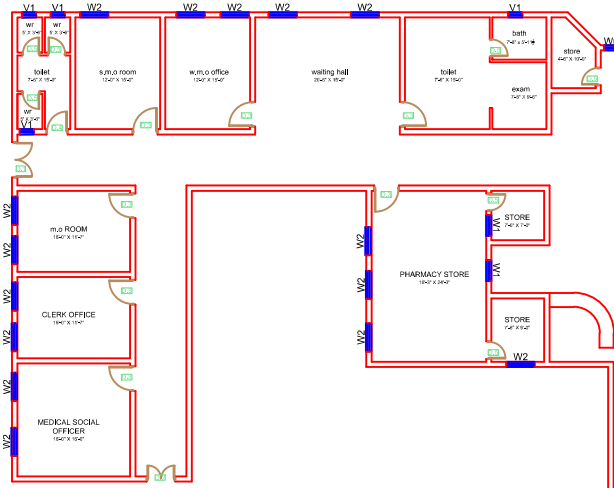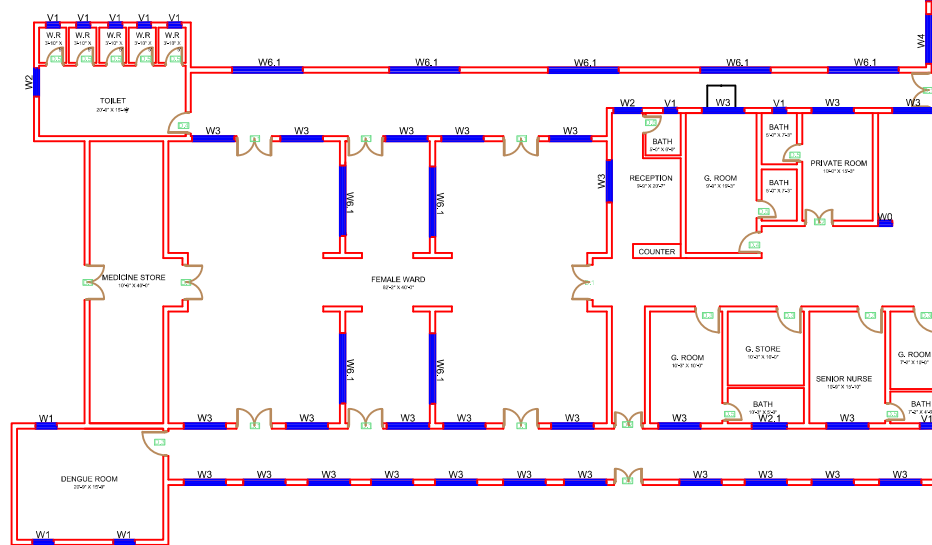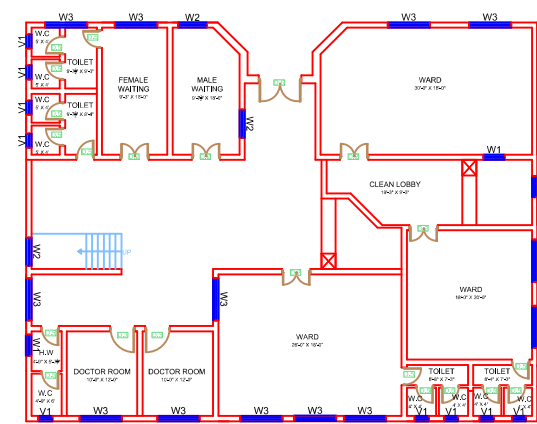

PART 4

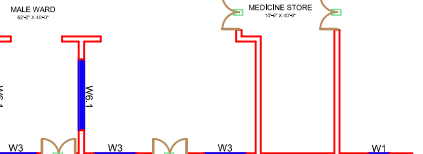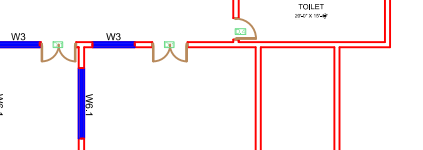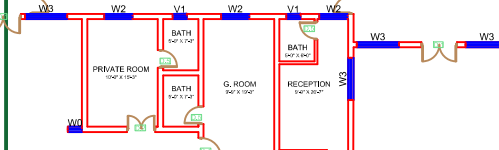

Drawing Title: THQ SHORKOT HOSPITAL CLINICAL BLOCK PLAN

Legends:

Residential Area	
Road	
Wall	
Power Line	
OHT	
Tree	
Man Hole	
Tube Well	
Light Pole	
Lawns	
Earthen Areas	
Asphalts Roads	
Tough Pavers	
P.C.C / Plinth Protection	
Boundary Wall	
Brick Pavers / Soling	
Drain	
Tap	
Hand Pump	
Air Conditioner	
Tube Light	
Fan	
Roof Light	
Bulb	

AREA	
AREA WITHIN BOUNDARY WALL	347041.43 Sft
AREA OF CLINICAL BLOCK	39148.43 Sft
PLINTH AREA OF BLOCK	36413.22 Sft

OPENING SCHEDULE OF DOORS AND WINDOWS




DOORS	WIDTH	HEIGHT	WINDOWS	WIDTH	HEIGHT
D1	5'-6"	7'-0"	W0	2'-0"	2'-0"
D2	5'-0"	7'-0"	W1	3'-0"	3'-0"
D3	4'-0"	7'-0"	W2	4'-0"	4'-0"
D4	3'-6"	7'-0"	W2.1	5'-0"	5'-0"
D5	3'-0"	7'-0"	W3	6'-0"	6'-0"
D6	2'-6"	7'-0"	W4	7'-0"	7'-0"
D7	6'-0"	7'-0"	W5	8'-0"	8'-0"
V1	2'-0"	2'-0"	W6	9'-0"	9'-0"
			W6.1	10'-0"	10'-0"

Project: CAD MAPPING OF TEHSIL HEAD QUARTER HOSPITALS, PUNJAB

Client: GOVERNMENT OF THE PUNJAB PRIMARY & SECONDARY HEALTHCARE DEPARTMENT	Consultant: SKAFS CONSULTANT (Pvt.) Limited ENGINEERING AND ENVIRONMENT CONSULTANT
---	---

Drawing No. SKAFS/SHORKOT /08

CLINICAL BLOCK OF THQ HOSPITAL SHORKOT GROUND FLOOR PART 1

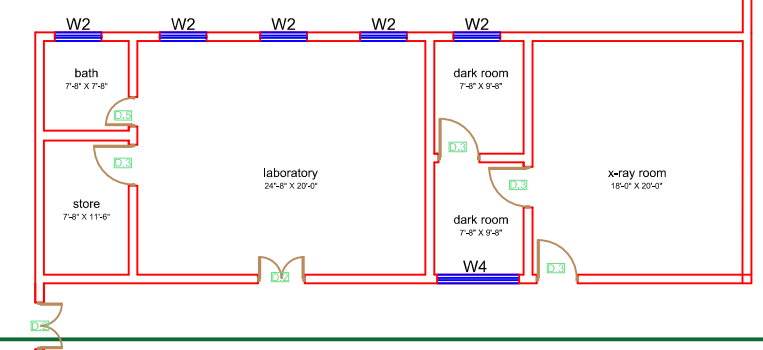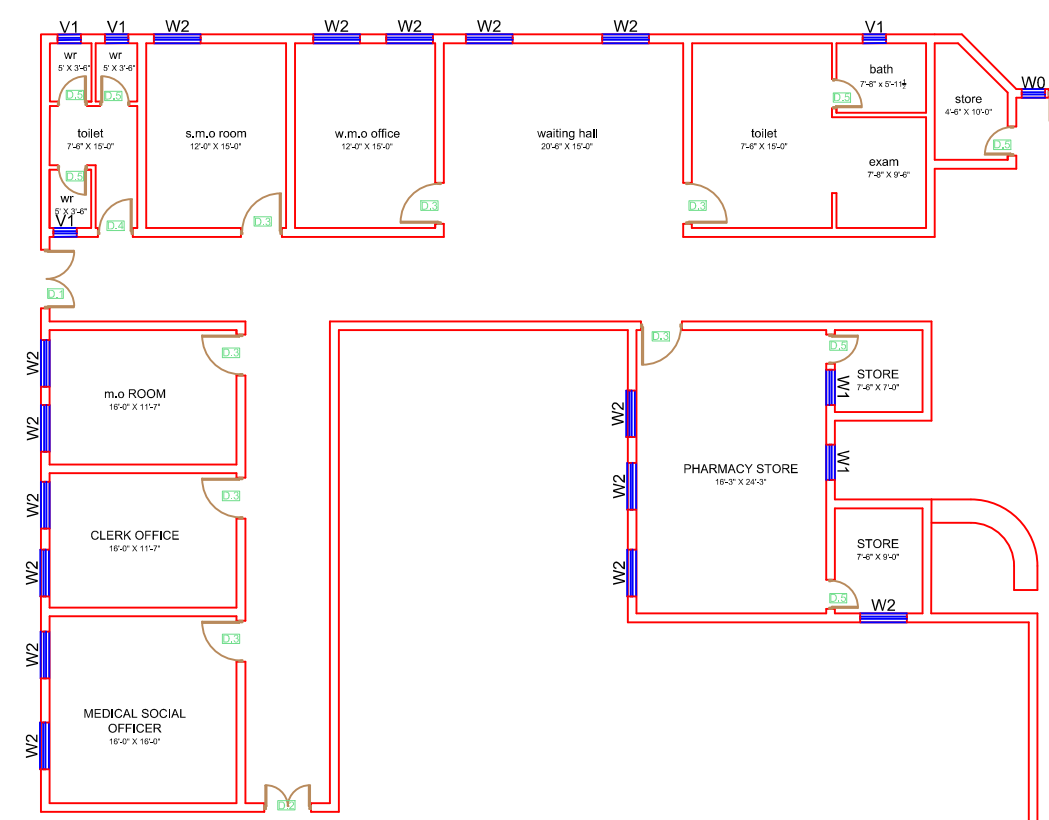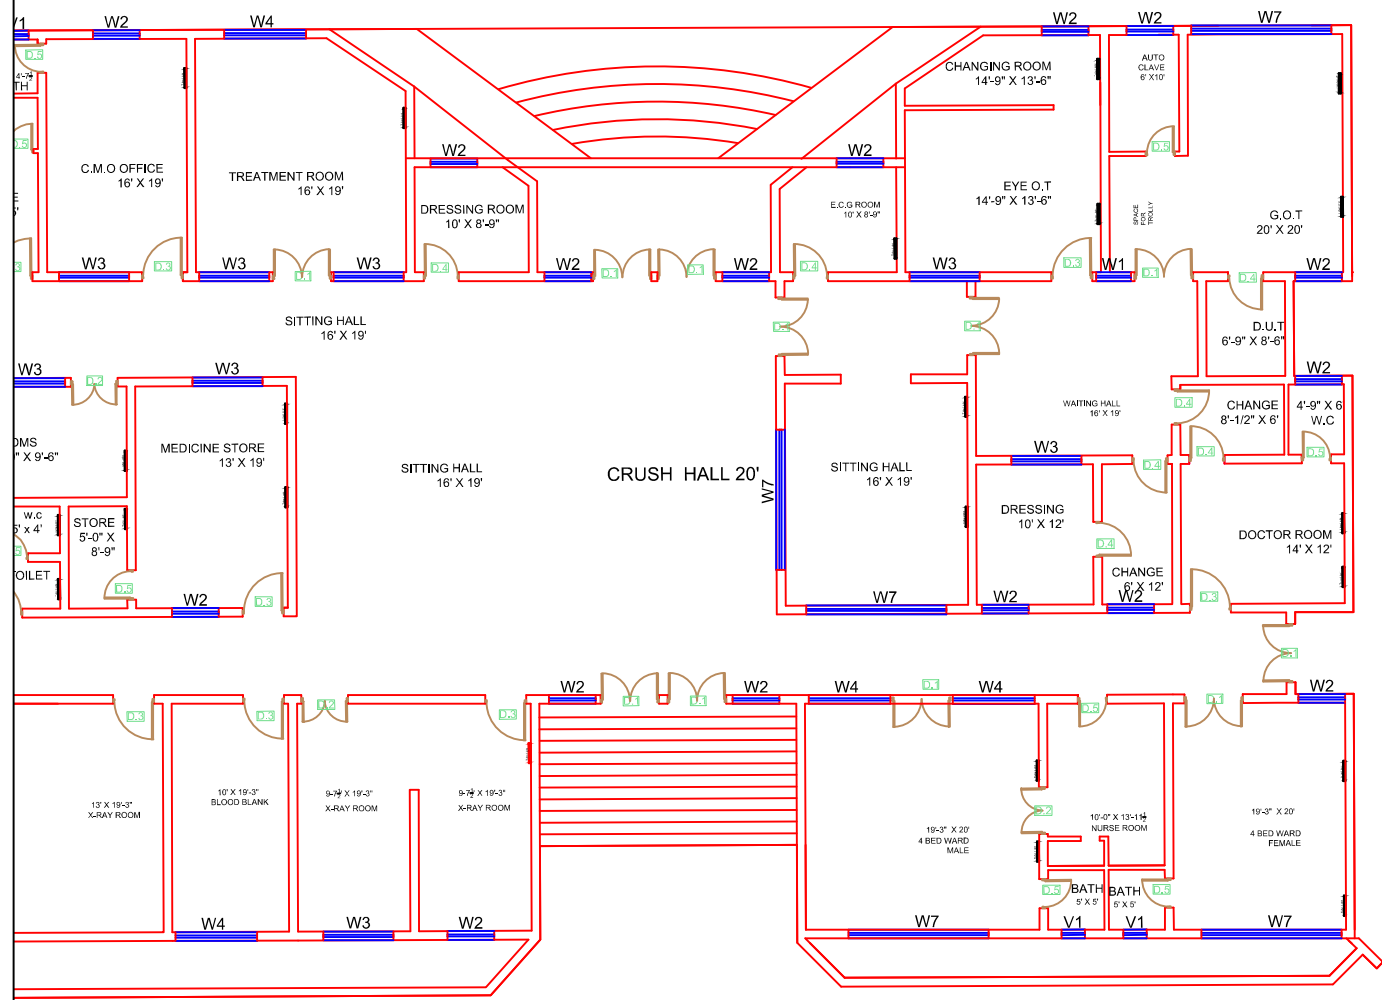

Legends:

Residential Area	
Road	
Wall	
Power Line	
OHT	
Tree	
Man Hole	
Tube Well	
Light Pole	
Lawns	
Earthen Areas	
Asphalts Roads	
Tough Pavers	
P.C.C / Plinth Protection	
Boundary Wall	
Brick Pavers / Soling	
Drain	
Tap	
Hand Pump	
Air Conditioner	
Tube Light	
Fan	
Roof Light	
Bulb	

AREA	
AREA WITHIN BOUNDARY WALL	347041.43 Sft
AREA OF CLINICAL BLOCK	39148.43 Sft
PLINTH AREA OF BLOCK	36413.22 Sft

OPENING SCHEDULE OF DOORS AND WINDOWS					
DOORS	WIDTH	HEIGHT	WINDOWS	WIDTH	HEIGHT
D1	5'-6"	7'-0"	W0	2'-0"	2'-0"
D2	5'-0"	7'-0"	W1	3'-0"	3'-0"
D3	4'-0"	7'-0"	W2	4'-0"	4'-0"
D4	3'-6"	7'-0"	W2.1	5'-0"	5'-0"
D5	3'-0"	7'-0"	W3	6'-0"	6'-0"
D6	2'-6"	7'-0"	W4	7'-0"	7'-0"
D7	6'-0"	7'-0"	W5	8'-0"	8'-0"
V1	2'-0"	2'-0"	W6	9'-0"	9'-0"
			W6.1	10'-0"	10'-0"

Project:
CAD MAPPING OF TEHSIL HEAD QUARTER HOSPITALS, PUNJAB


Client: GOVERNMENT OF THE PUNJAB PRIMARY & SECONDARY HEALTHCARE DEPARTMENT	Consultant: SKAFS CONSULTANT (Pvt.) Limited ENGINEERING AND ENVIRONMENT CONSULTANT
---	--

Drawing Title:
**THQ SHORKOT
CLINICAL BLOCK PLAN (PART 1)**

Drawing No. **SKAFS/SHORKOT /09**

CLINICAL BLOCK OF THQ HOSPITAL SHORKOT

GROUND FLOOR PART 2

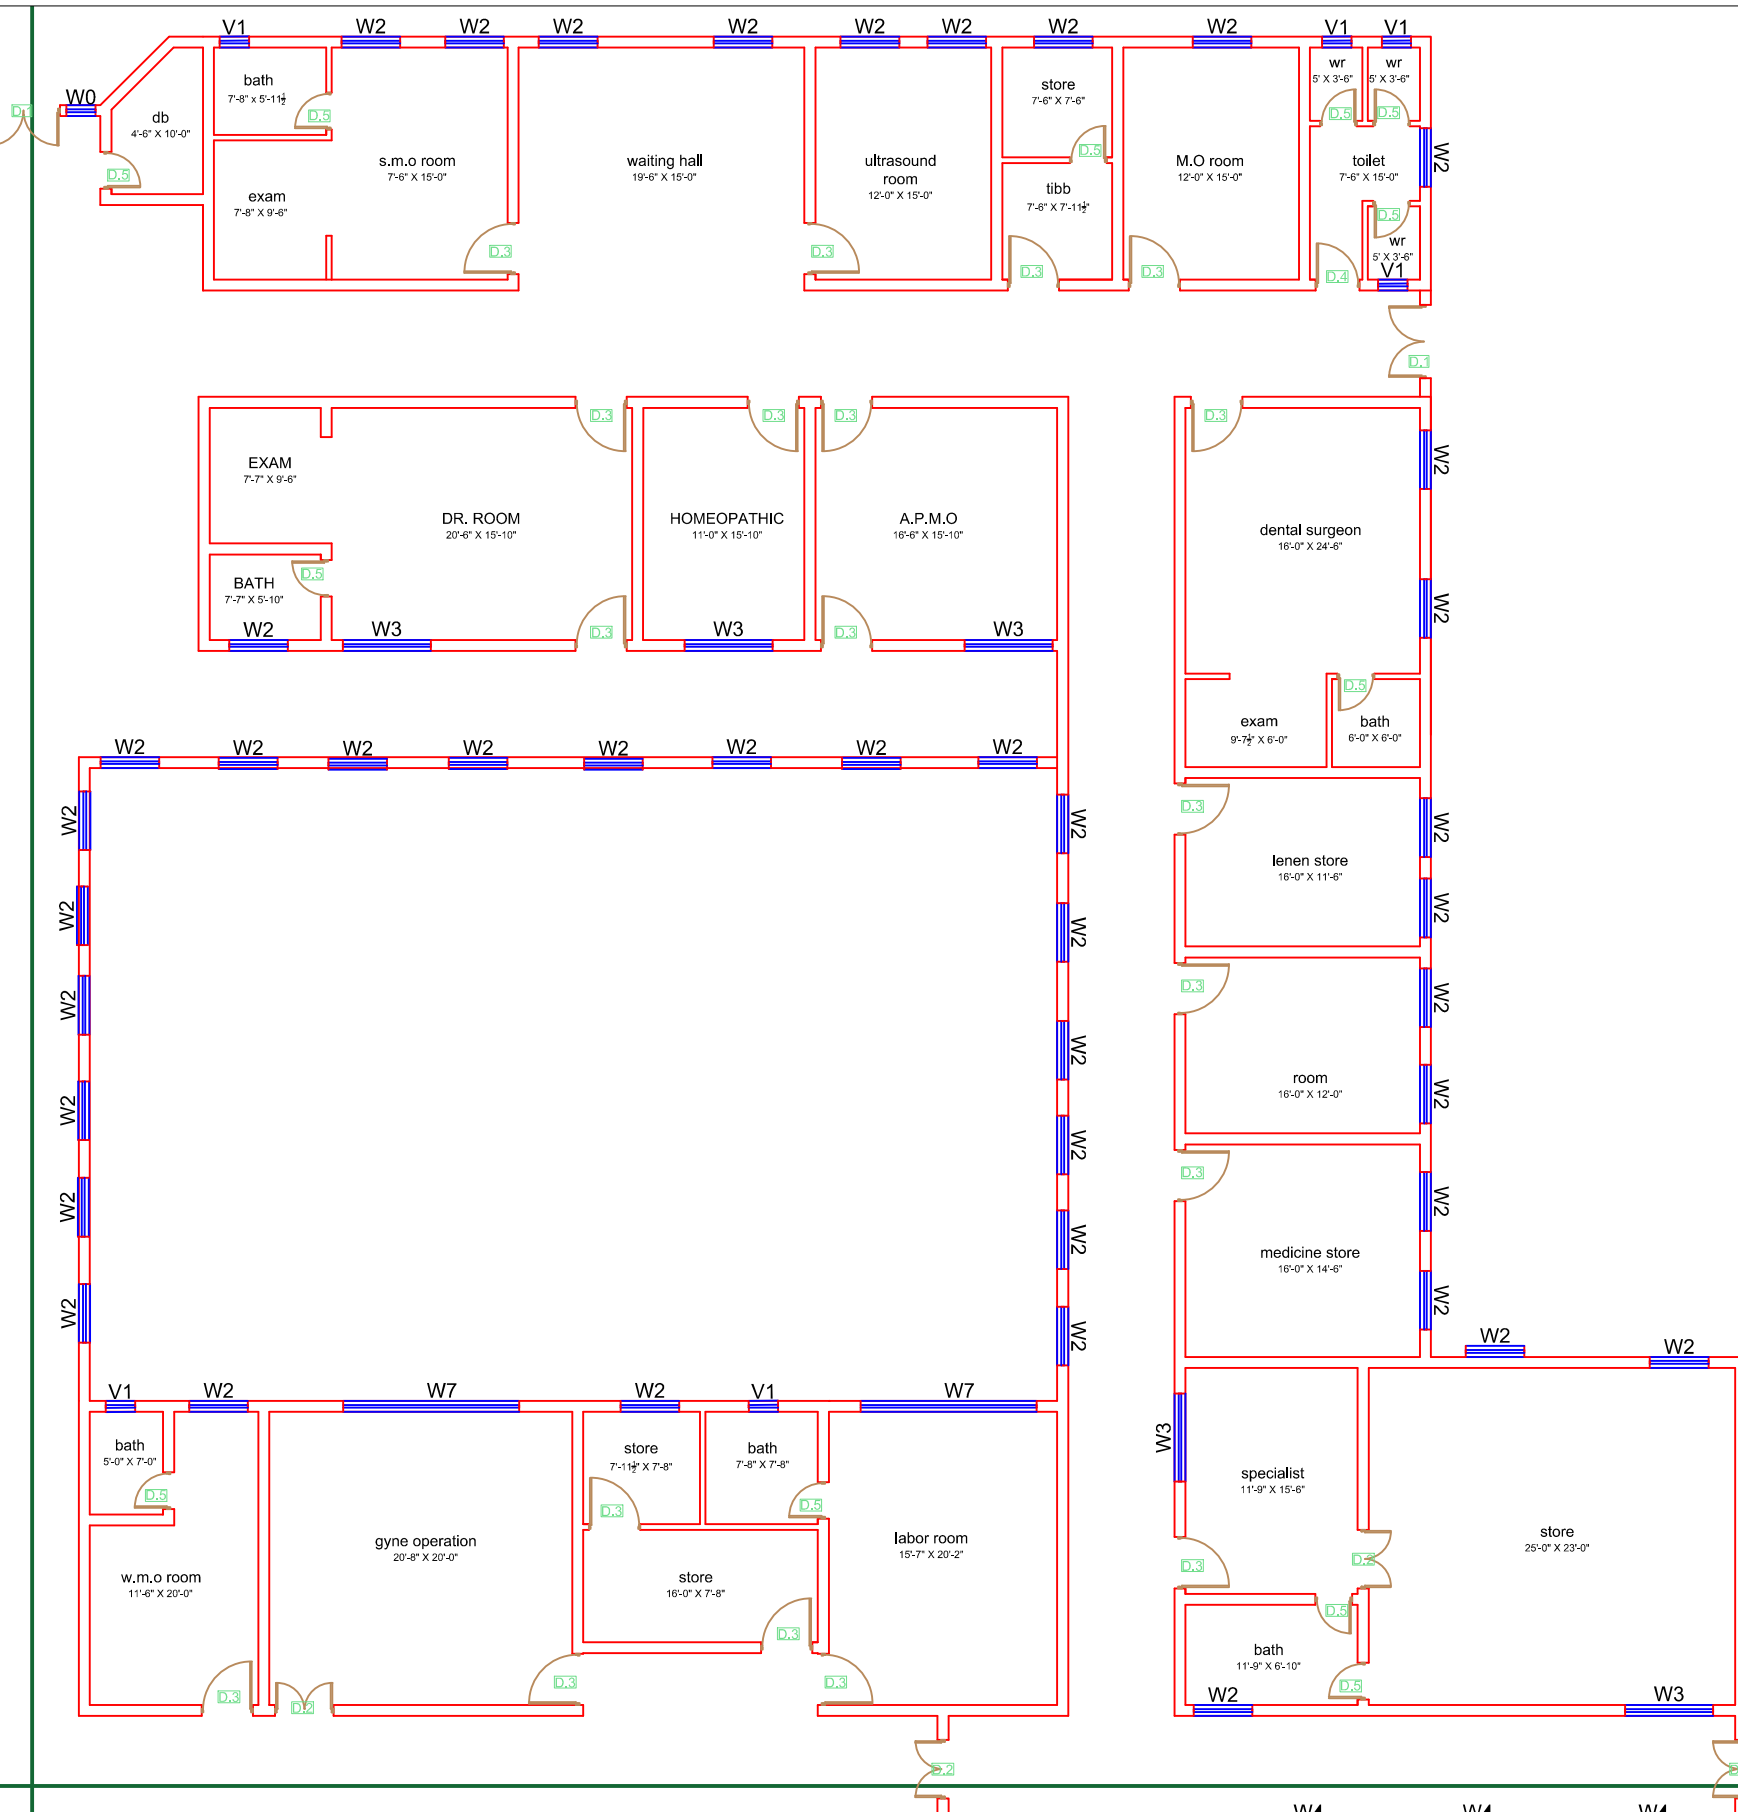

Legends:

Residential Area	
Road	
Wall	
Power Line	
OHT	
Tree	
Man Hole	
Tube Well	
Light Pole	
Lawns	
Earthen Areas	
Asphalts Roads	
Tough Pavers	
P.C.C / Plinth Protection	
Boundary Wall	
Brick Pavers / Soling	
Drain	
Tap	
Hand Pump	
Air Conditioner	
Tube Light	
Fan	
Roof Light	
Bulb	

AREA

AREA WITHIN BOUNDARY WALL	347041.43 Sft
AREA OF CLINICAL BLOCK	39148.43 Sft
PLINTH AREA OF BLOCK	36413.22 Sft

OPENING SCHEDULE OF DOORS AND WINDOWS

DOORS	WIDTH	HEIGHT	WINDOWS	WIDTH	HEIGHT
D1	5'-6"	7'-0"	W0	2'-0"	2'-0"
D2	5'-0"	7'-0"	W1	3'-0"	3'-0"
D3	4'-0"	7'-0"	W2	4'-0"	4'-0"
D4	3'-6"	7'-0"	W2.1	5'-0"	5'-0"
D5	3'-0"	7'-0"	W3	6'-0"	6'-0"
D6	2'-6"	7'-0"	W4	7'-0"	7'-0"
D7	6'-0"	7'-0"	W5	8'-0"	8'-0"
V1	2'-0"	2'-0"	W6	9'-0"	9'-0"
			W6.1	10'-0"	10'-0"

Project:
CAD MAPPING OF TEHSIL HEAD QUARTER HOSPITALS, PUNJAB

Client: GOVERNMENT OF THE PUNJAB
PRIMARY & SECONDARY HEALTHCARE DEPARTMENT


Consultant: SKAFS CONSULTANT (Pvt.) Limited
ENGINEERING AND ENVIRONMENT CONSULTANT

Drawing Title: **THQ SHORKOT CLINICAL BLOCK PLAN (PART 2)**

Drawing No. **SKAFS/SHORKOT /10**

CLINICAL BLOCK OF THQ HOSPITAL SHORKOT

GROUND FLOOR PART 3

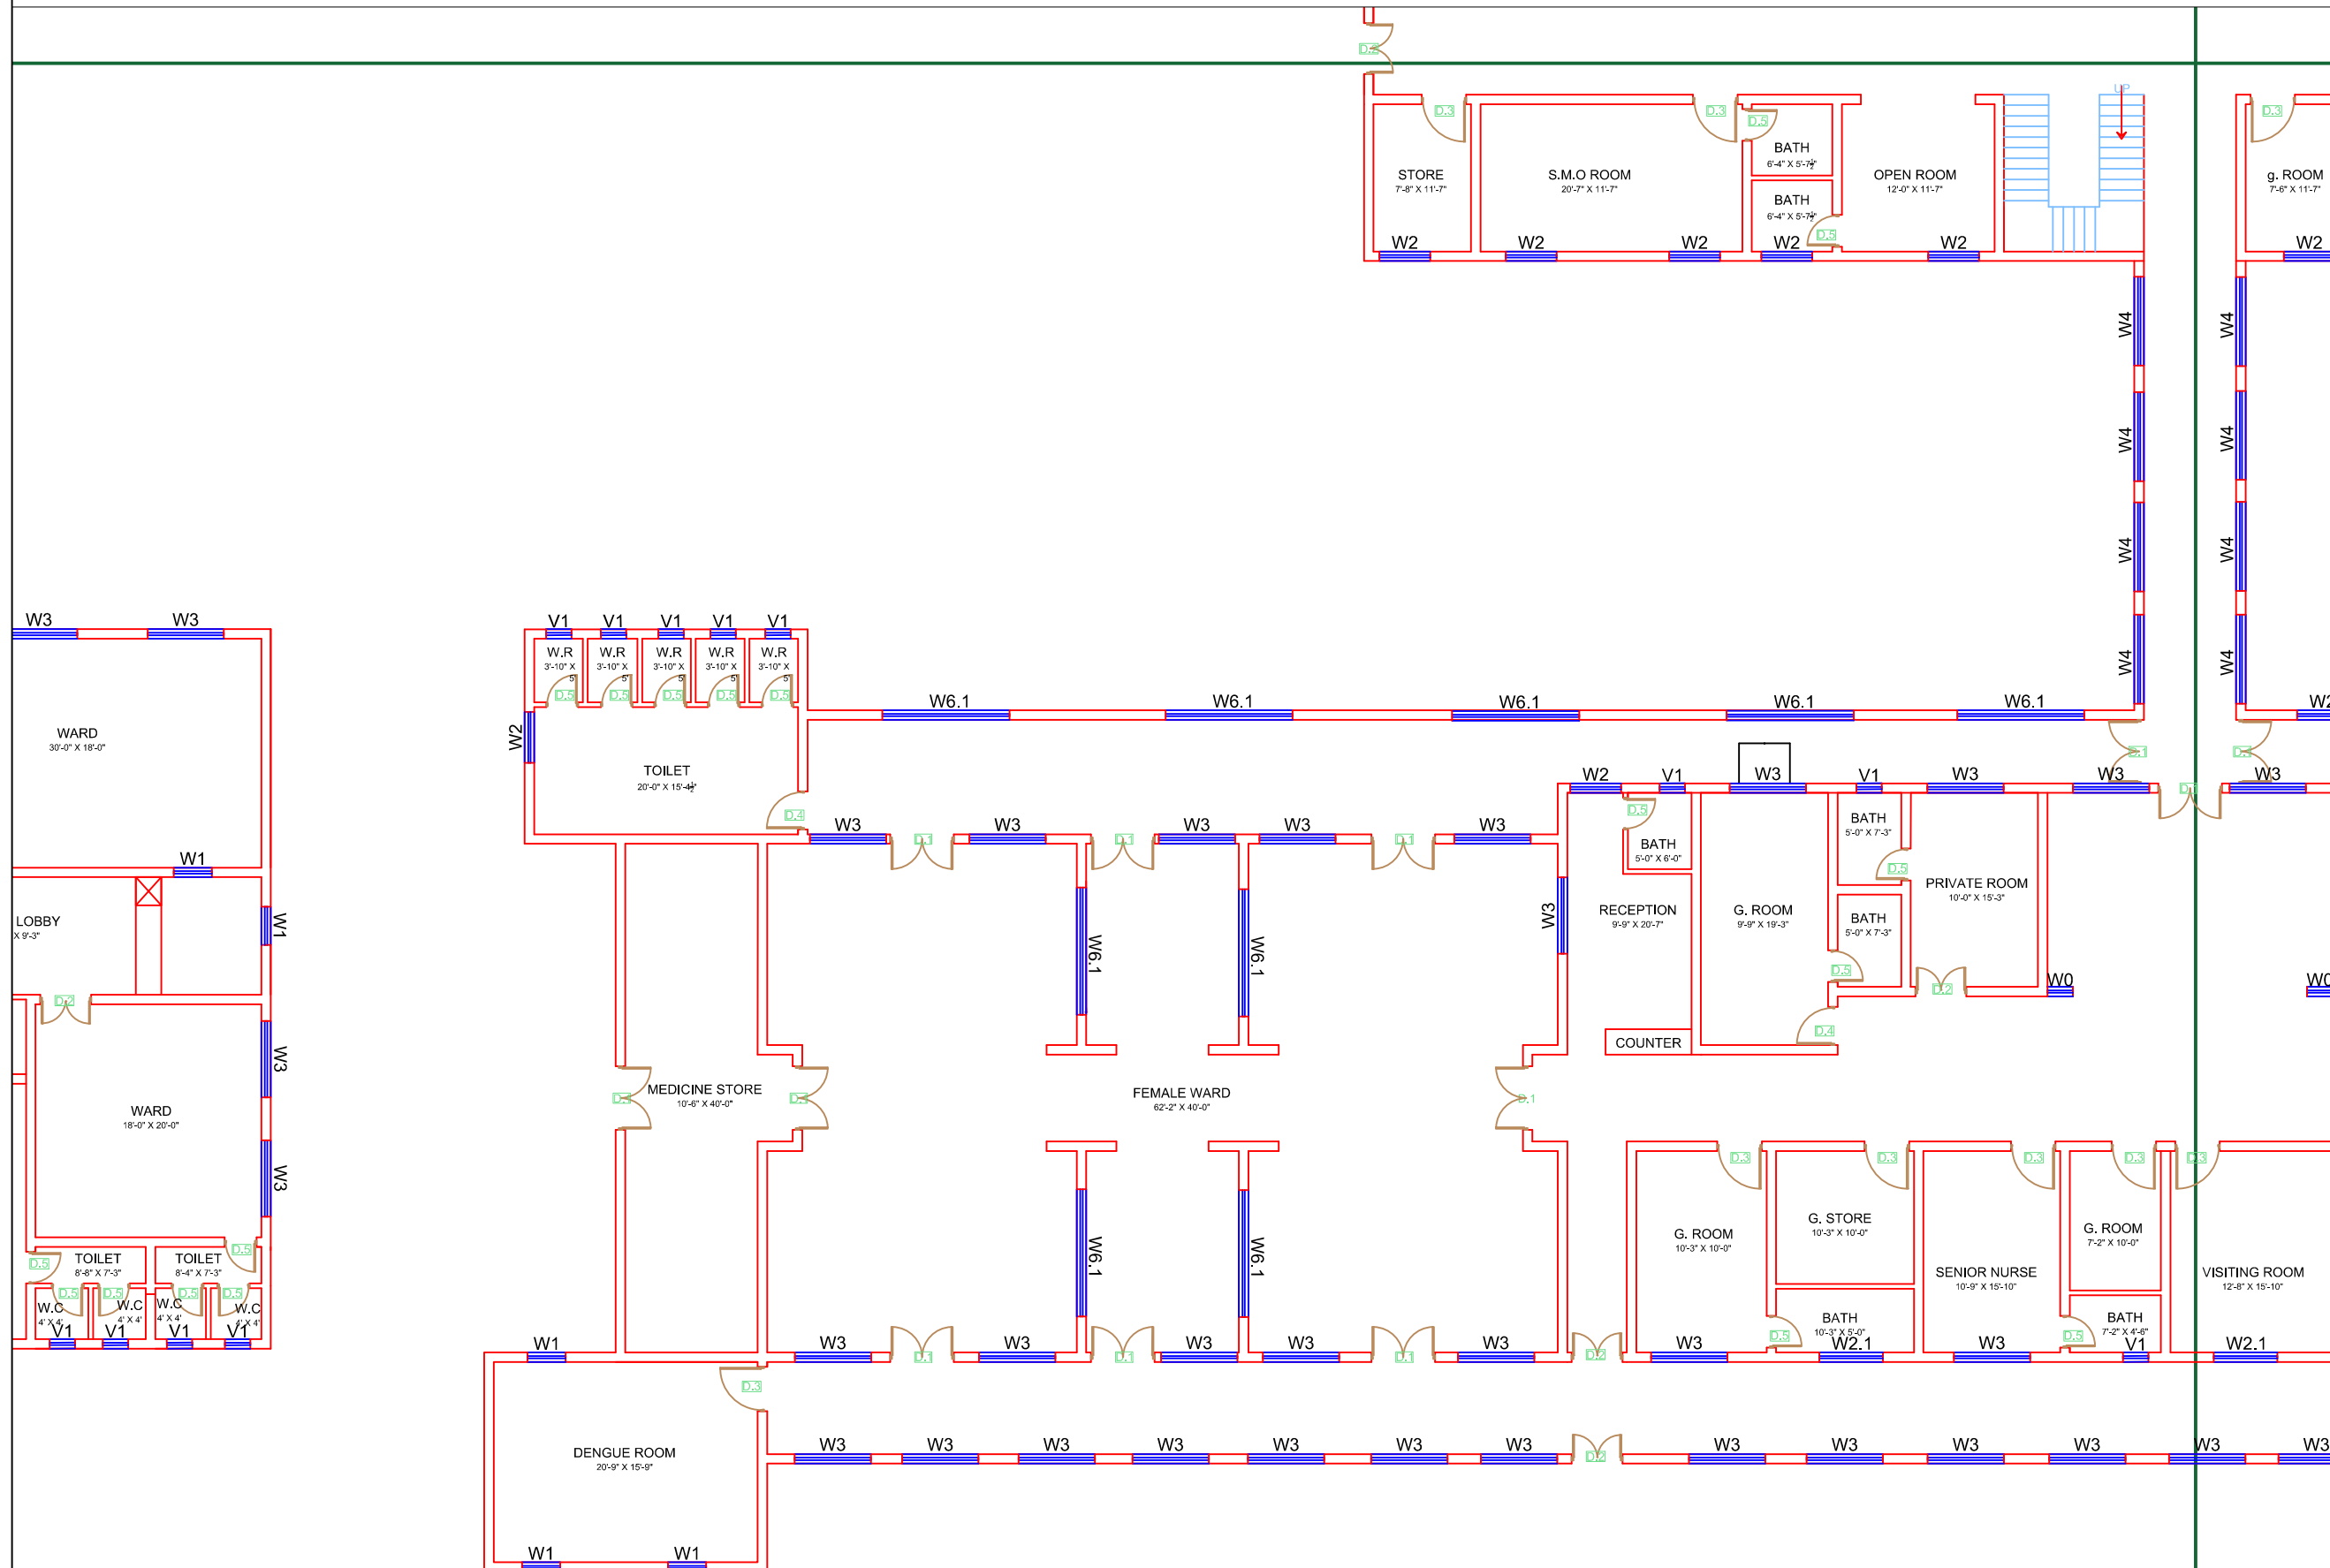

Legends:

Residential Area	
Road	
Wall	
Power Line	
OHT	
Tree	
Man Hole	
Tube Well	
Light Pole	
Lawns	
Earthen Areas	
Asphalts Roads	
Tough Pavers	
P.C.C / Plinth Protection	
Boundary Wall	
Brick Pavers / Soling	
Drain	
Tap	
Hand Pump	
Air Conditioner	
Tube Light	
Fan	
Roof Light	
Bulb	

AREA	
AREA WITHIN BOUNDARY WALL	347041.43 Sft
AREA OF CLINICAL BLOCK	39148.43 Sft
PLINTH AREA OF BLOCK	36413.22 Sft

OPENING SCHEDULE OF DOORS AND WINDOWS					
DOORS	WIDTH	HEIGHT	WINDOWS	WIDTH	HEIGHT
D1	5'-6"	7'-0"	W0	2'-0"	2'-0"
D2	5'-0"	7'-0"	W1	3'-0"	3'-0"
D3	4'-0"	7'-0"	W2	4'-0"	4'-0"
D4	3'-6"	7'-0"	W2.1	5'-0"	5'-0"
D5	3'-0"	7'-0"	W3	6'-0"	6'-0"
D6	2'-6"	7'-0"	W4	7'-0"	7'-0"
D7	6'-0"	7'-0"	W5	8'-0"	8'-0"
V1	2'-0"	2'-0"	W6	9'-0"	9'-0"
			W6.1	10'-0"	10'-0"

Project:
CAD MAPPING OF TEHSIL HEAD QUARTER HOSPITALS, PUNJAB


Client: GOVERNMENT OF THE PUNJAB PRIMARY & SECONDARY HEALTHCARE DEPARTMENT	Consultant: SKAFS CONSULTANT (Pvt.) Limited ENGINEERING AND ENVIRONMENT CONSULTANT
---	--

Drawing Title:
THQ SHORKOT CLINICAL BLOCK PLAN (PART 3)

Drawing No.
SKAFS/SHORKOT /11

CLINICAL BLOCK OF THQ HOSPITAL SHORKOT

GROUND FLOOR PART 4

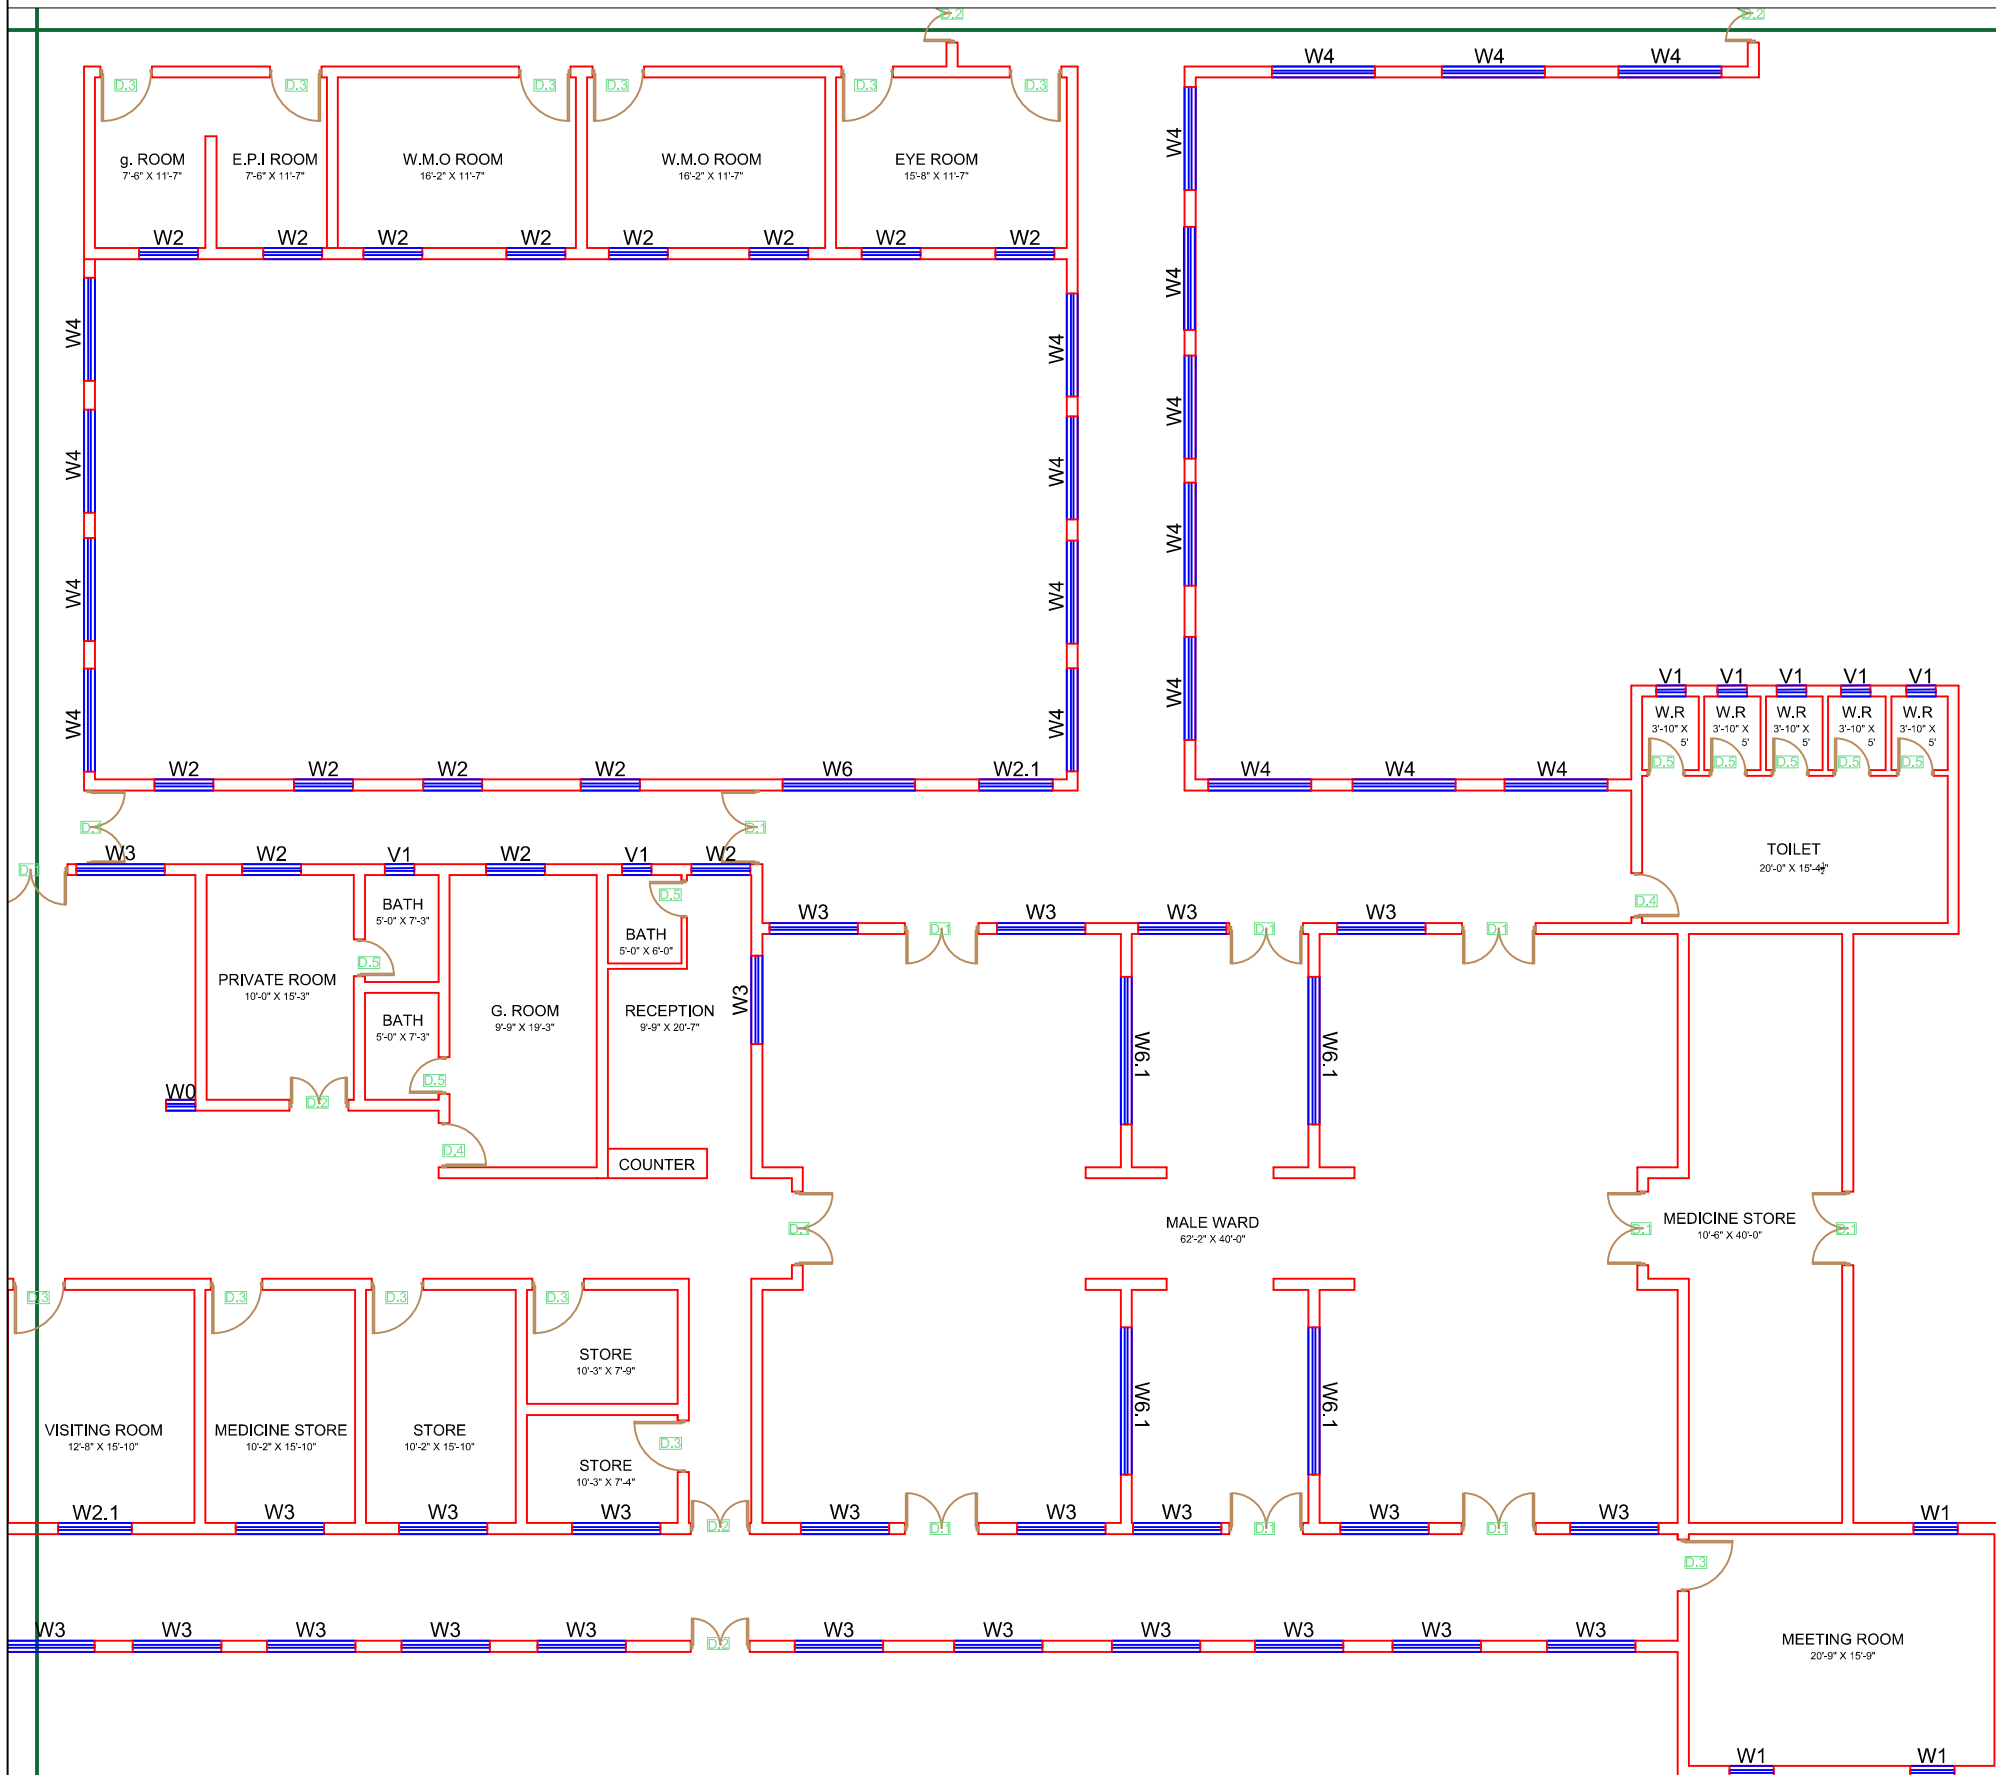

Legends:

Residential Area	
Road	
Wall	
Power Line	
OHT	
Tree	
Man Hole	
Tube Well	
Light Pole	
Lawns	
Earthen Areas	
Asphalts Roads	
Tough Pavers	
P.C.C / Plinth Protection	
Boundary Wall	
Brick Pavers / Soling	
Drain	
Tap	
Hand Pump	
Air Conditioner	
Tube Light	
Fan	
Roof Light	
Bulb	

AREA	
AREA WITHIN BOUNDARY WALL	347041.43 Sft
AREA OF CLINICAL BLOCK	39148.43 Sft
PLINTH AREA OF BLOCK	36413.22 Sft

OPENING SCHEDULE OF DOORS AND WINDOWS					
DOORS	WIDTH	HEIGHT	WINDOWS	WIDTH	HEIGHT
D1	5'-6"	7'-0"	W0	2'-0"	2'-0"
D2	5'-0"	7'-0"	W1	3'-0"	3'-0"
D3	4'-0"	7'-0"	W2	4'-0"	4'-0"
D4	3'-6"	7'-0"	W2.1	5'-0"	5'-0"
D5	3'-0"	7'-0"	W3	6'-0"	6'-0"
D6	2'-6"	7'-0"	W4	7'-0"	7'-0"
D7	6'-0"	7'-0"	W5	8'-0"	8'-0"
V1	2'-0"	2'-0"	W6	9'-0"	9'-0"
			W6.1	10'-0"	10'-0"

Project:
CAD MAPPING OF TEHSIL HEAD QUARTER HOSPITALS, PUNJAB

Client: GOVERNMENT OF THE PUNJAB
 PRIMARY & SECONDARY HEALTHCARE DEPARTMENT


Consultant: SKAFS CONSULTANT (Pvt.) Limited
 ENGINEERING AND ENVIRONMENT CONSULTANT

Drawing Title: **THQ SHORKOT CLINICAL BLOCK PLAN (PART 4)**

Drawing No. **SKAFS/SHORKOT /12**

CLINICAL BLOCK OF THQ HOSPITAL SHORKOT

FIRST FLOOR PART 1

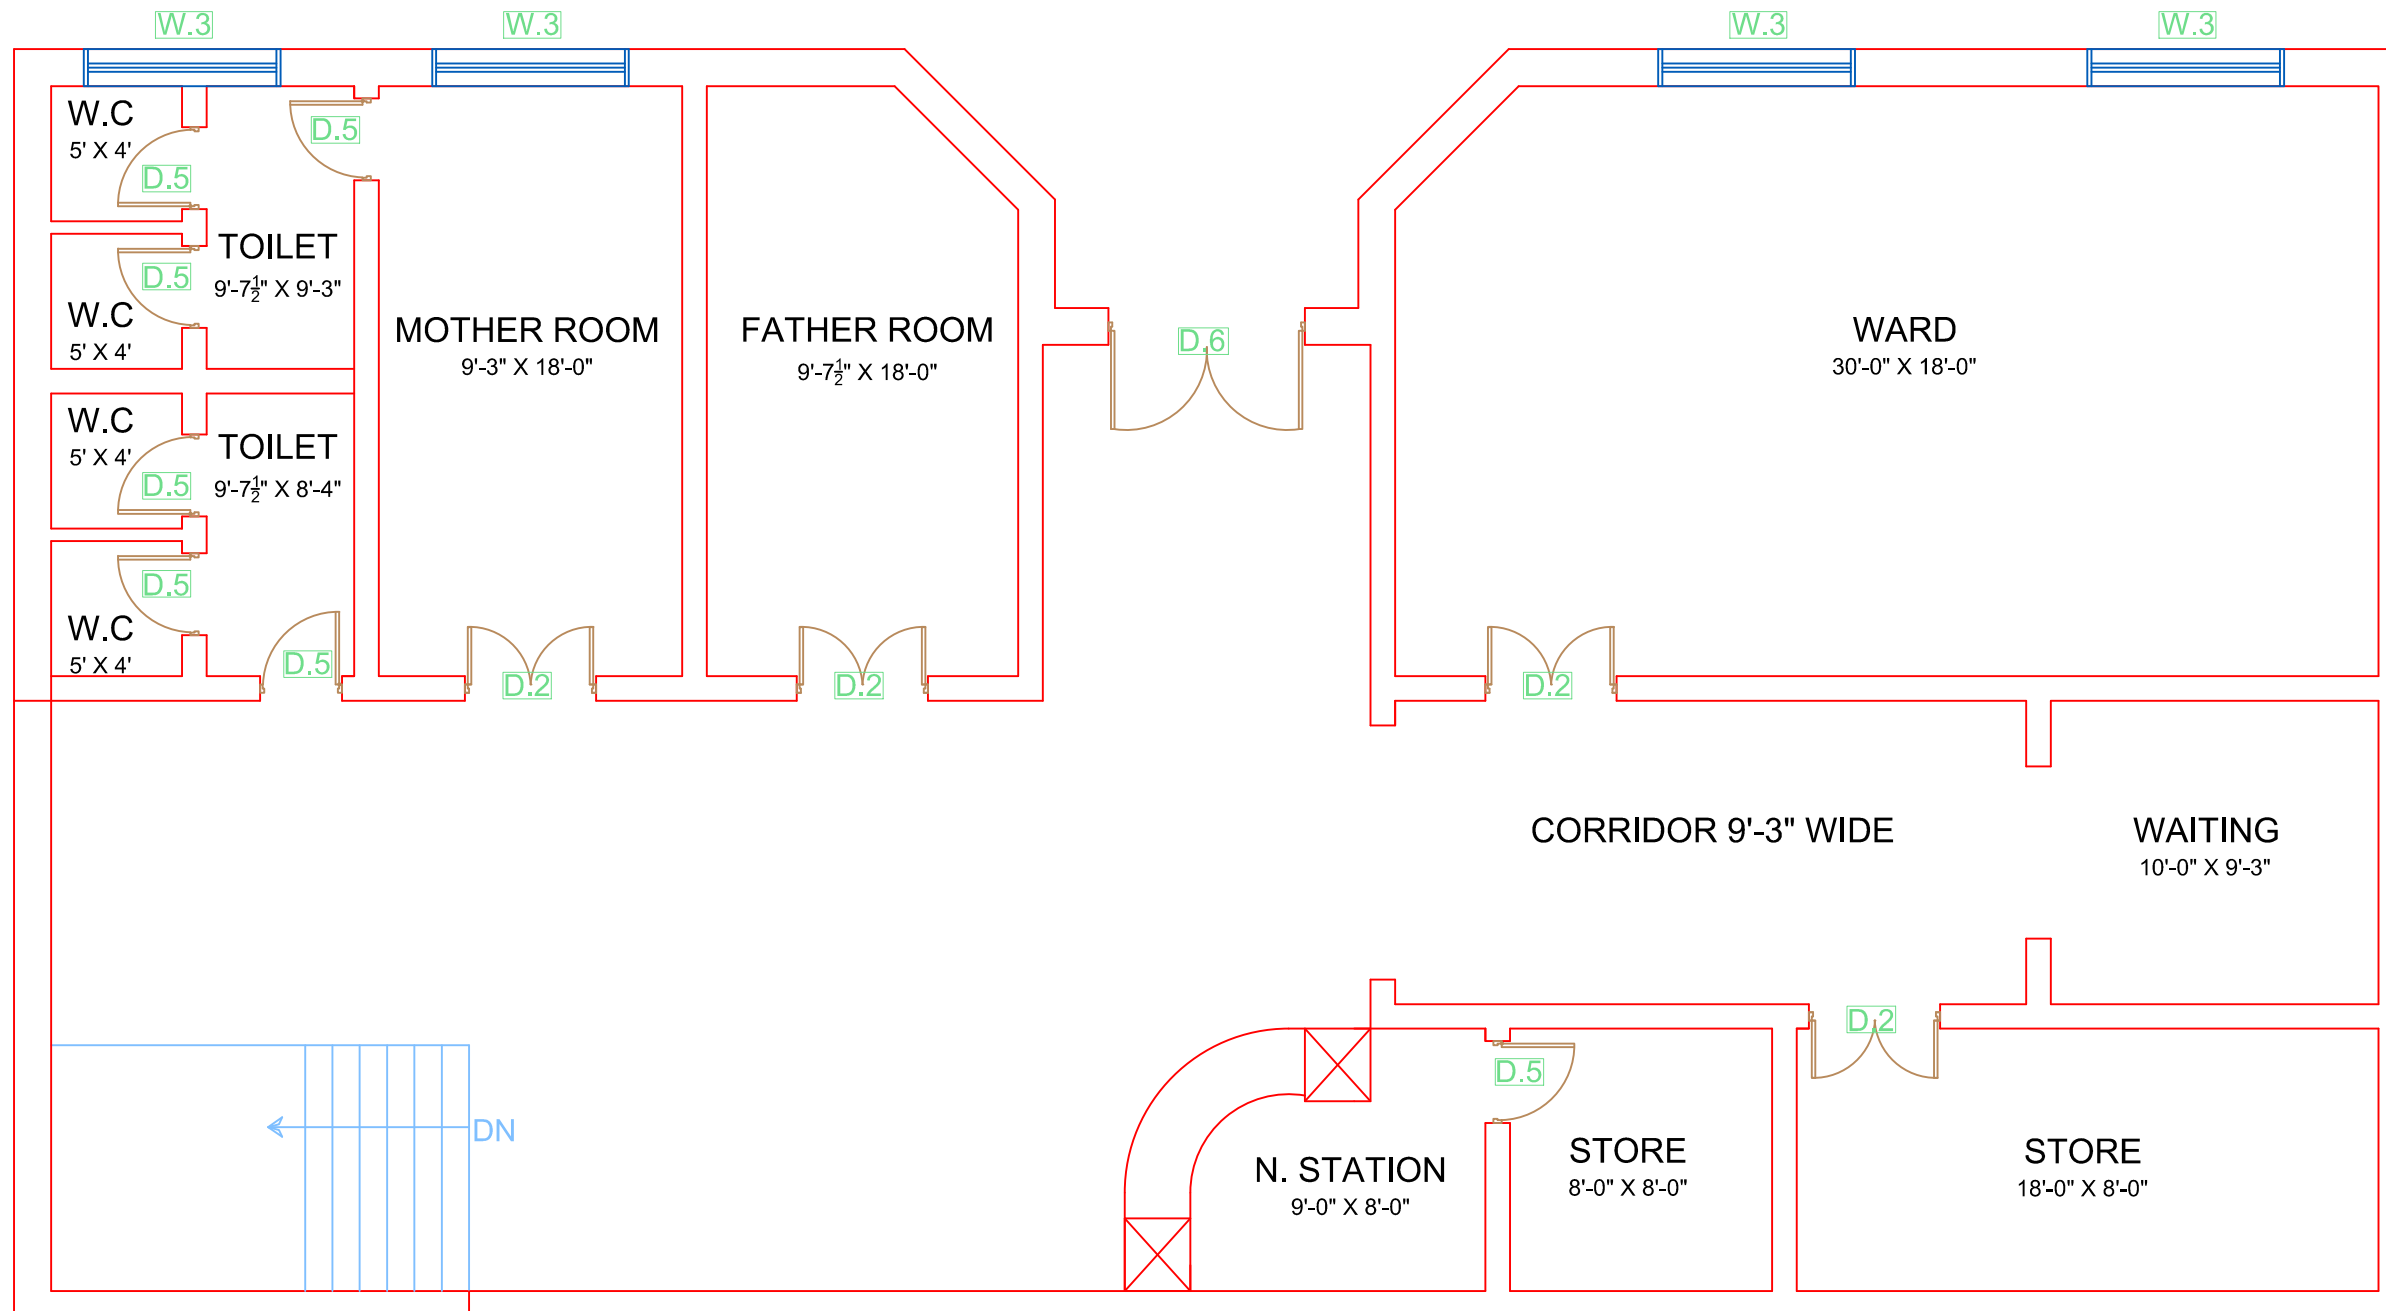

Legends:

Residential Area	
Road	
Wall	
Power Line	
OHT	
Tree	
Man Hole	
Tube Well	
Light Pole	
Lawns	
Earthen Areas	
Asphalts Roads	
Tough Pavers	
P.C.C / Plinth Protection	
Boundary Wall	
Brick Pavers / Soling	
Drain	
Tap	
Hand Pump	
Air Conditioner	
Tube Light	
Fan	
Roof Light	
Bulb	

AREA	
AREA WITHIN BOUNDARY WALL	347041.43 Sft
AREA OF CLINICAL BLOCK	39148.43 Sft
PLINTH AREA OF BLOCK	36413.22 Sft

OPENING SCHEDULE OF DOORS AND WINDOWS					
DOORS	WIDTH	HEIGHT	WINDOWS	WIDTH	HEIGHT
D1	5'-6"	7'-0"	W0	2'-0"	2'-0"
D2	5'-0"	7'-0"	W1	3'-0"	3'-0"
D3	4'-0"	7'-0"	W2	4'-0"	4'-0"
D4	3'-6"	7'-0"	W2.1	5'-0"	5'-0"
D5	3'-0"	7'-0"	W3	6'-0"	6'-0"
D6	2'-6"	7'-0"	W4	7'-0"	7'-0"
D7	6'-0"	7'-0"	W5	8'-0"	8'-0"
V1	2'-0"	2'-0"	W6	9'-0"	9'-0"
			W6.1	10'-0"	10'-0"


Project:
CAD MAPPING OF TEHSIL HEAD QUARTER HOSPITALS, PUNJAB

Client:	Consultant:
 GOVERNMENT OF THE PUNJAB PRIMARY & SECONDARY HEALTHCARE DEPARTMENT	 SKAFS CONSULTANT (Pvt.) Limited ENGINEERING AND ENVIRONMENT CONSULTANT

Drawing Title:
**THQ SHORKOT
 FIRST FLOOR PLAN (PART 1)**

Drawing No.
SKAFS/SHORKOT /13

ELECTRICAL LAYOUT PLAN OF THQ HOSPITAL SHORKOT GROUND FLOOR

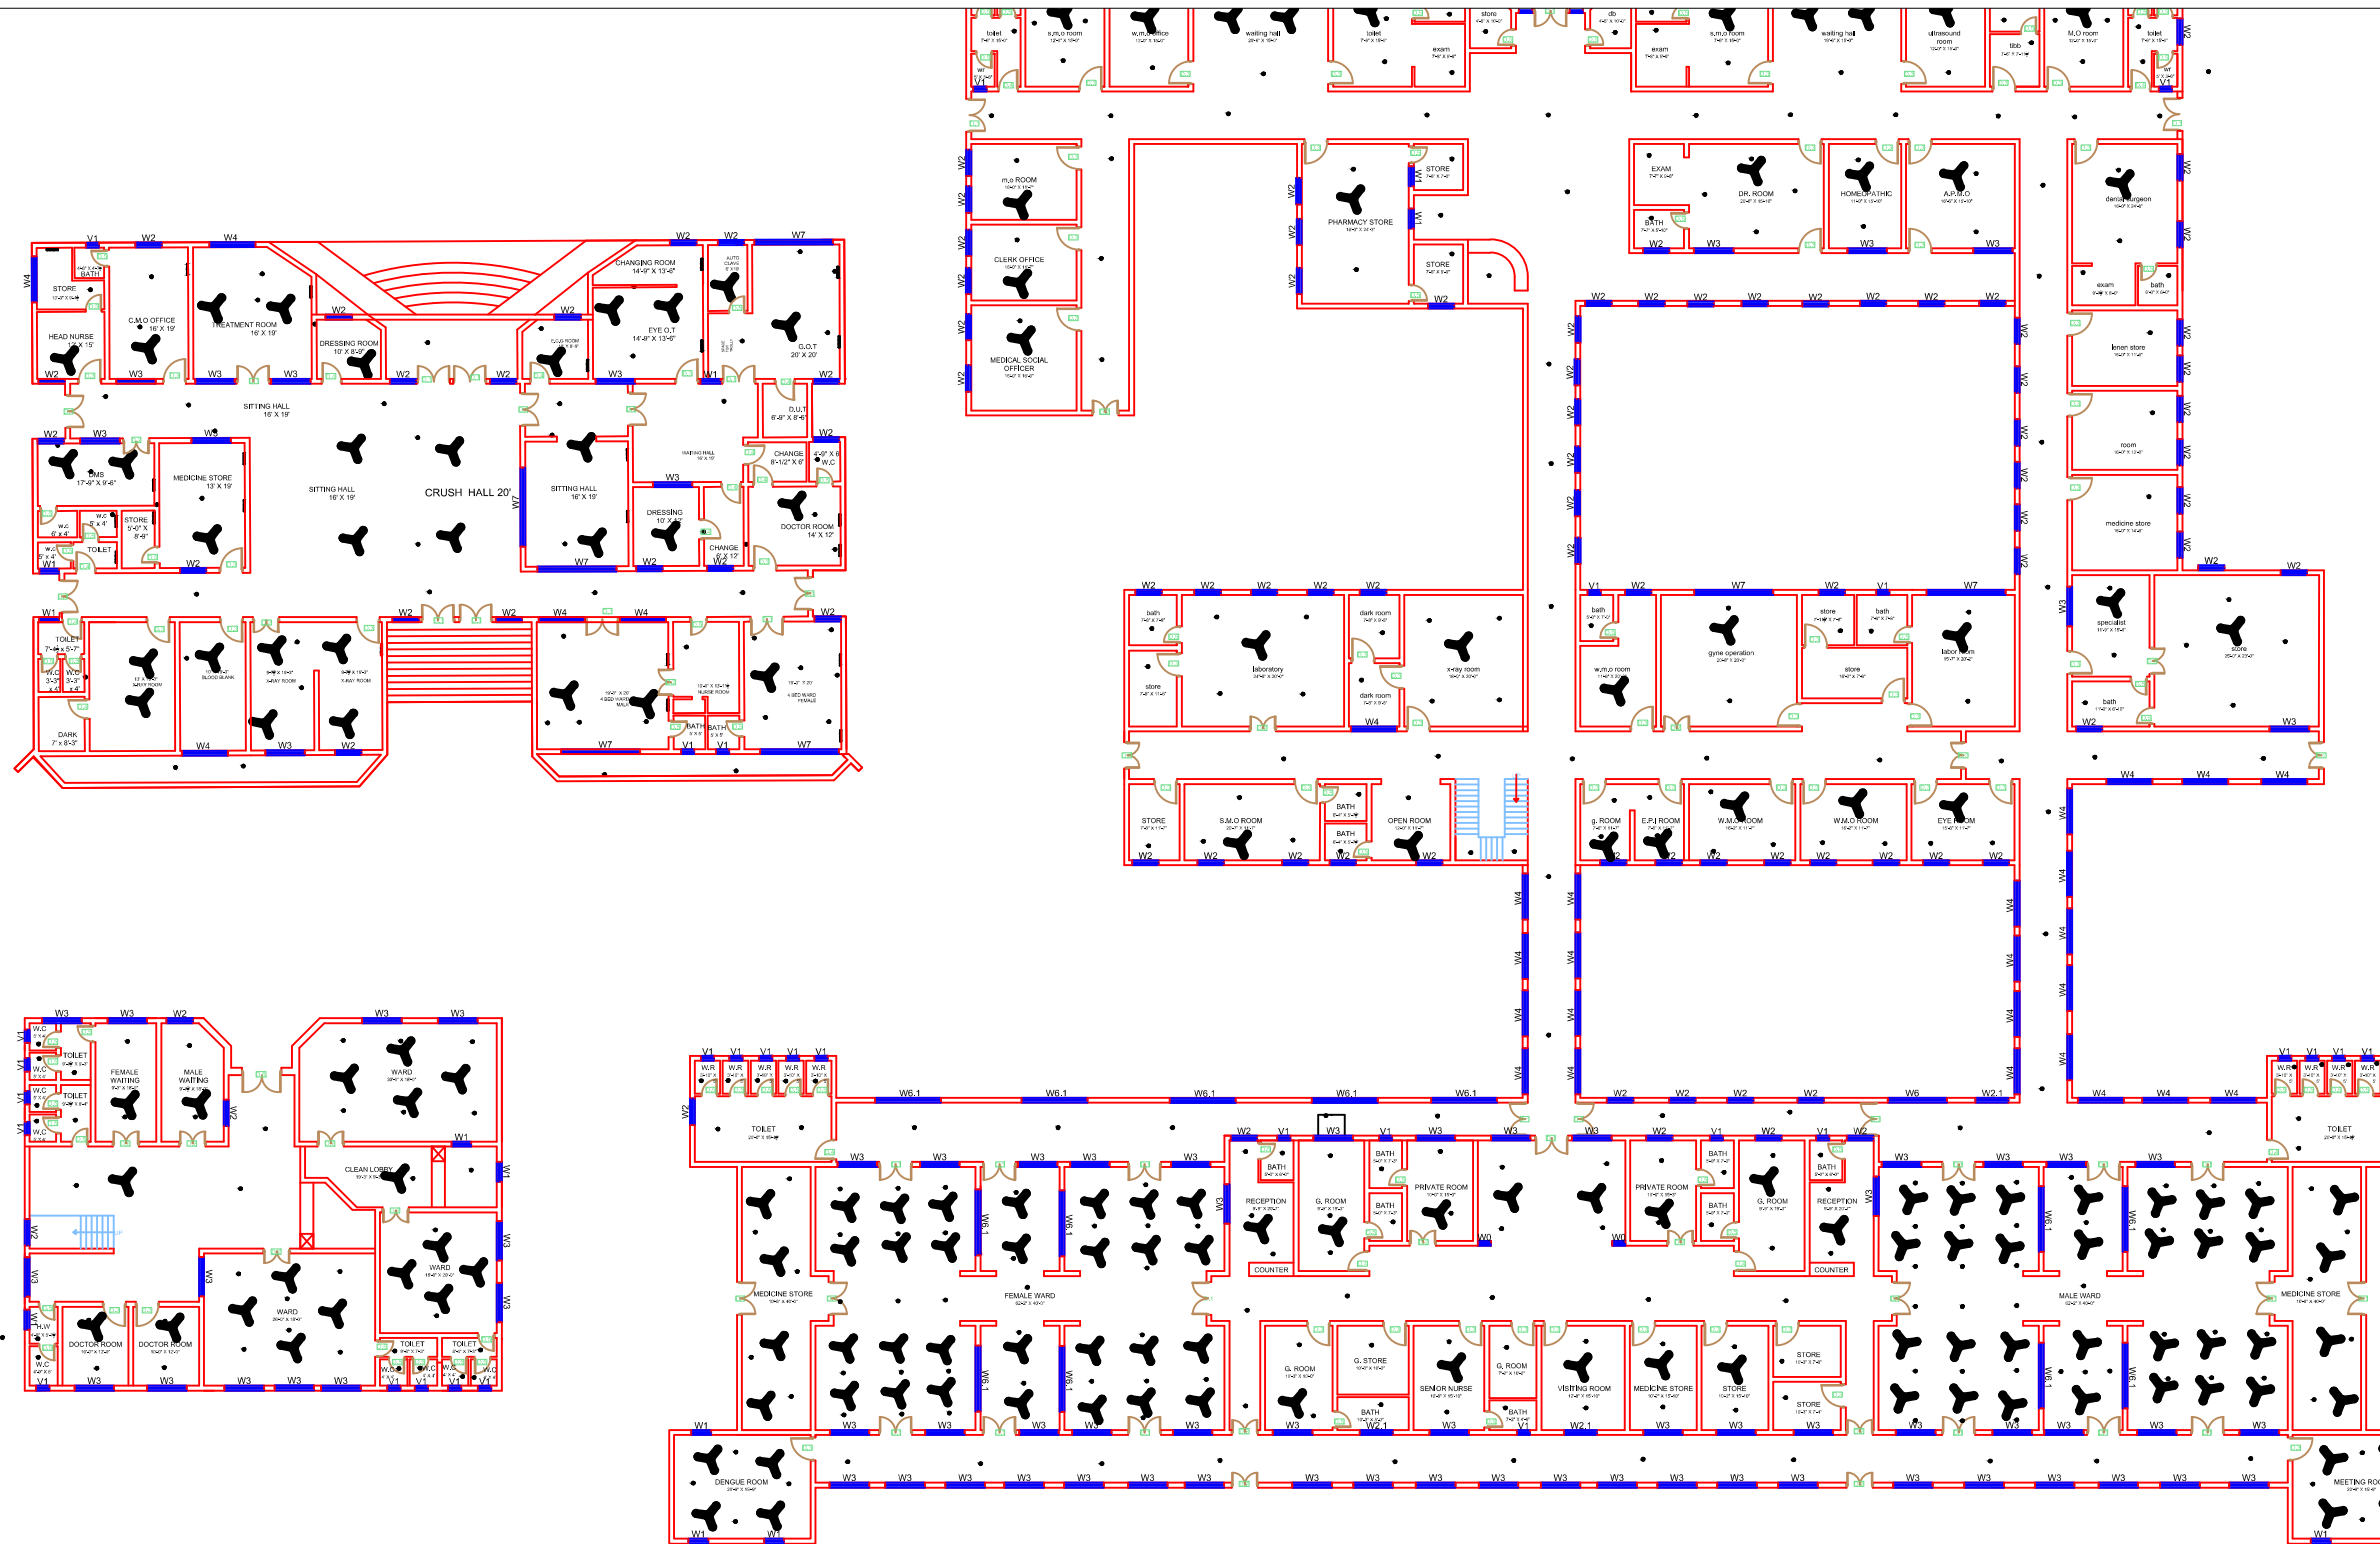

Legends:

Residential Area	
Road	
Wall	
Power Line	
OHT	
Tree	
Man Hole	
Tube Well	
Light Pole	
Lawns	
Earthen Areas	
Asphalts Roads	
Tough Pavers	
P.C.C / Plinth Protection	
Boundary Wall	
Brick Pavers / Soling	
Drain	
Tap	
Hand Pump	
Air Conditioner	
Tube Light	
Fan	
Roof Light	
Bulb	

AREA

AREA WITHIN BOUNDARY WALL	347041.43 Sft
AREA OF CLINICAL BLOCK	39148.43 Sft
PLINTH AREA OF BLOCK	36413.22 Sft

OPENING SCHEDULE OF DOORS AND WINDOWS

DOORS	WIDTH	HEIGHT	WINDOWS	WIDTH	HEIGHT
D1	5'-6"	7'-0"	W0	2'-0"	2'-0"
D2	5'-0"	7'-0"	W1	3'-0"	3'-0"
D3	4'-0"	7'-0"	W2	4'-0"	4'-0"
D4	3'-6"	7'-0"	W2.1	5'-0"	5'-0"
D5	3'-0"	7'-0"	W3	6'-0"	6'-0"
D6	2'-6"	7'-0"	W4	7'-0"	7'-0"
D7	6'-0"	7'-0"	W5	8'-0"	8'-0"
V1	2'-0"	2'-0"	W6	9'-0"	9'-0"
			W6.1	10'-0"	10'-0"


Project:
**CAD MAPPING OF TEHSIL
HEAD QUARTER HOSPITALS,
PUNJAB**

Client: GOVERNMENT OF THE PUNJAB PRIMARY & SECONDARY HEALTHCARE DEPARTMENT	Consultant: SKAFS CONSULTANT (Pvt.) Limited ENGINEERING AND ENVIRONMENT CONSULTANT
---	--

Drawing Title:
**THQ SHORKOT
ELECTRICAL PLAN (GROUND FLOOR)**

Drawing No.
SKAFS/SHORKOT /14

ELECTRICAL LAYOUT PLAN OF THQ HOSPITAL SHORKOT FIRST FLOOR

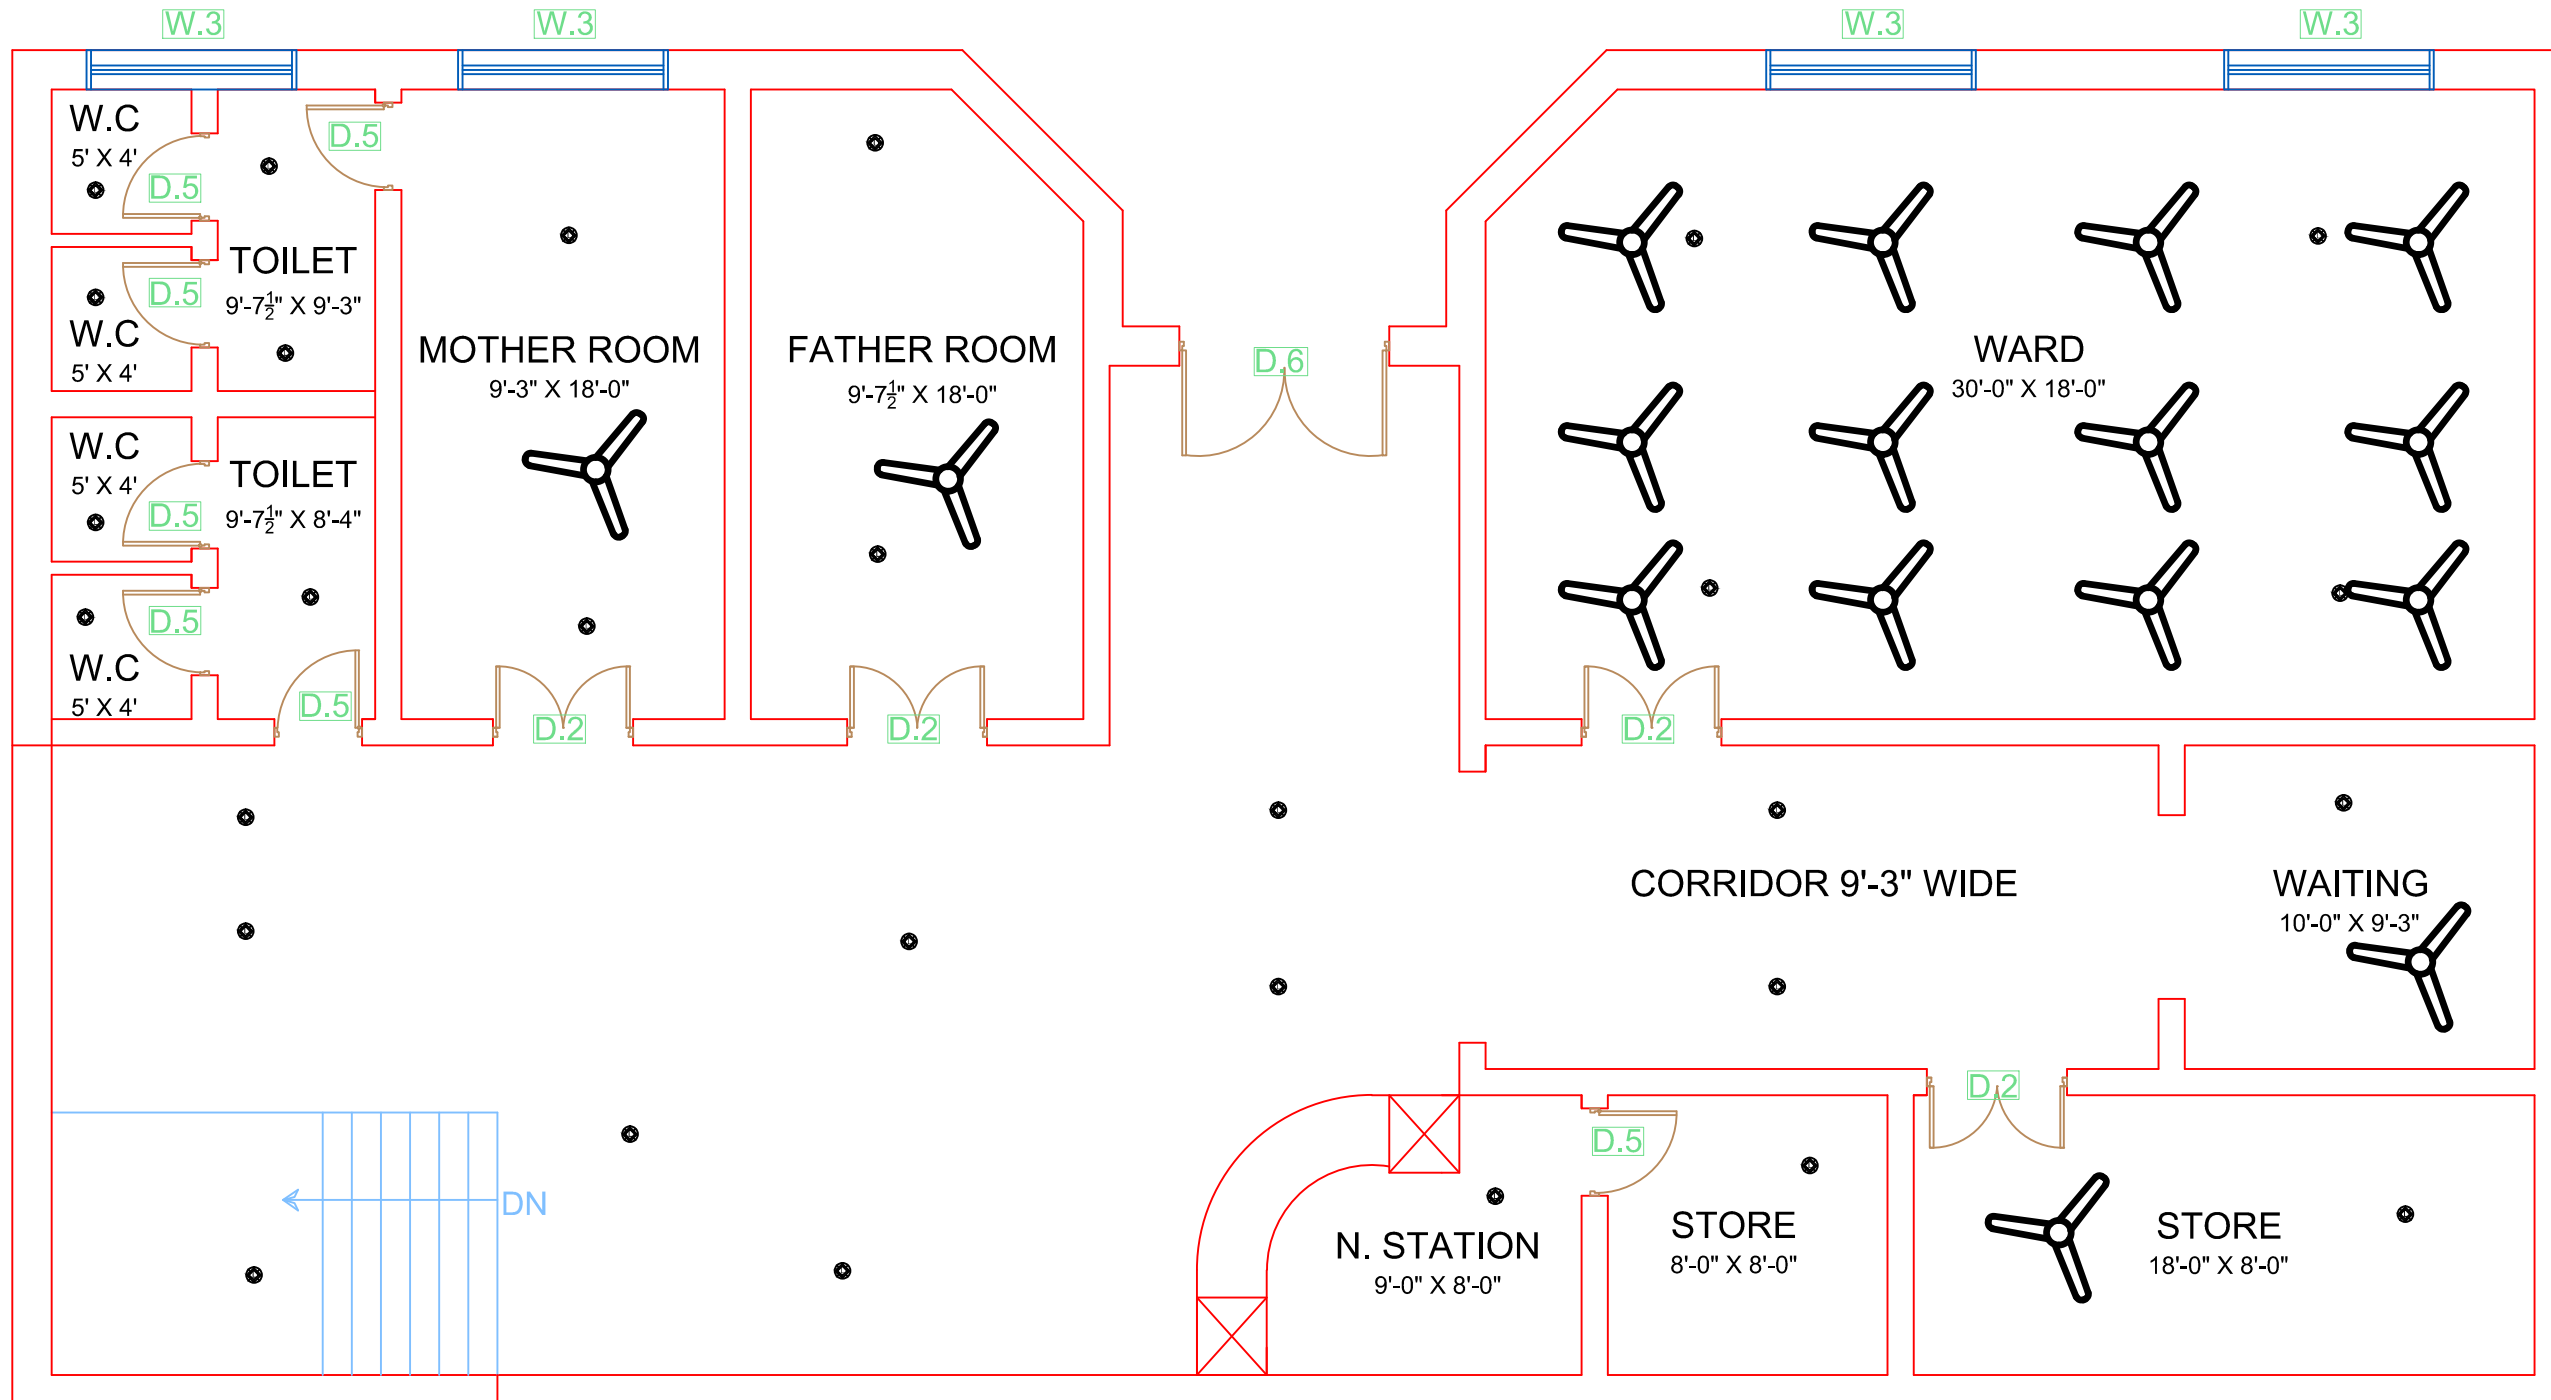

Legends:

Residential Area	
Road	
Wall	
Power Line	
OHT	
Tree	
Man Hole	
Tube Well	
Light Pole	
Lawns	
Earthen Areas	
Asphalts Roads	
Tough Pavers	
P.C.C / Plinth Protection	
Boundary Wall	
Brick Pavers / Soling	
Drain	
Tap	
Hand Pump	
Air Conditioner	
Tube Light	
Fan	
Roof Light	
Bulb	

AREA	
AREA WITHIN BOUNDARY WALL	347041.43 Sft
AREA OF CLINICAL BLOCK	39148.43 Sft
PLINTH AREA OF BLOCK	36413.22 Sft

OPENING SCHEDULE OF DOORS AND WINDOWS					
DOORS	WIDTH	HEIGHT	WINDOWS	WIDTH	HEIGHT
D1	5'-6"	7'-0"	W0	2'-0"	2'-0"
D2	5'-0"	7'-0"	W1	3'-0"	3'-0"
D3	4'-0"	7'-0"	W2	4'-0"	4'-0"
D4	3'-6"	7'-0"	W2.1	5'-0"	5'-0"
D5	3'-0"	7'-0"	W3	6'-0"	6'-0"
D6	2'-6"	7'-0"	W4	7'-0"	7'-0"
D7	6'-0"	7'-0"	W5	8'-0"	8'-0"
V1	2'-0"	2'-0"	W6	9'-0"	9'-0"
			W6.1	10'-0"	10'-0"

Project:
**CAD MAPPING OF TEHSIL
HEAD QUARTER HOSPITALS,
PUNJAB**

Client: GOVERNMENT OF THE PUNJAB PRIMARY & SECONDARY HEALTHCARE DEPARTMENT	Consultant: SKAFS CONSULTANT (Pvt.) Limited ENGINEERING AND ENVIRONMENT CONSULTANT
---	--

Drawing Title:
**THQ SHORKOT
ELECTRICAL PLAN (FIRST FLOOR)**

Drawing No.
SKAFS/SHORKOT /15