


# MASTER PLAN OF THQ HOSPITAL TALAGANG CITY

PART 1

PART 2

PART 3

PART 4

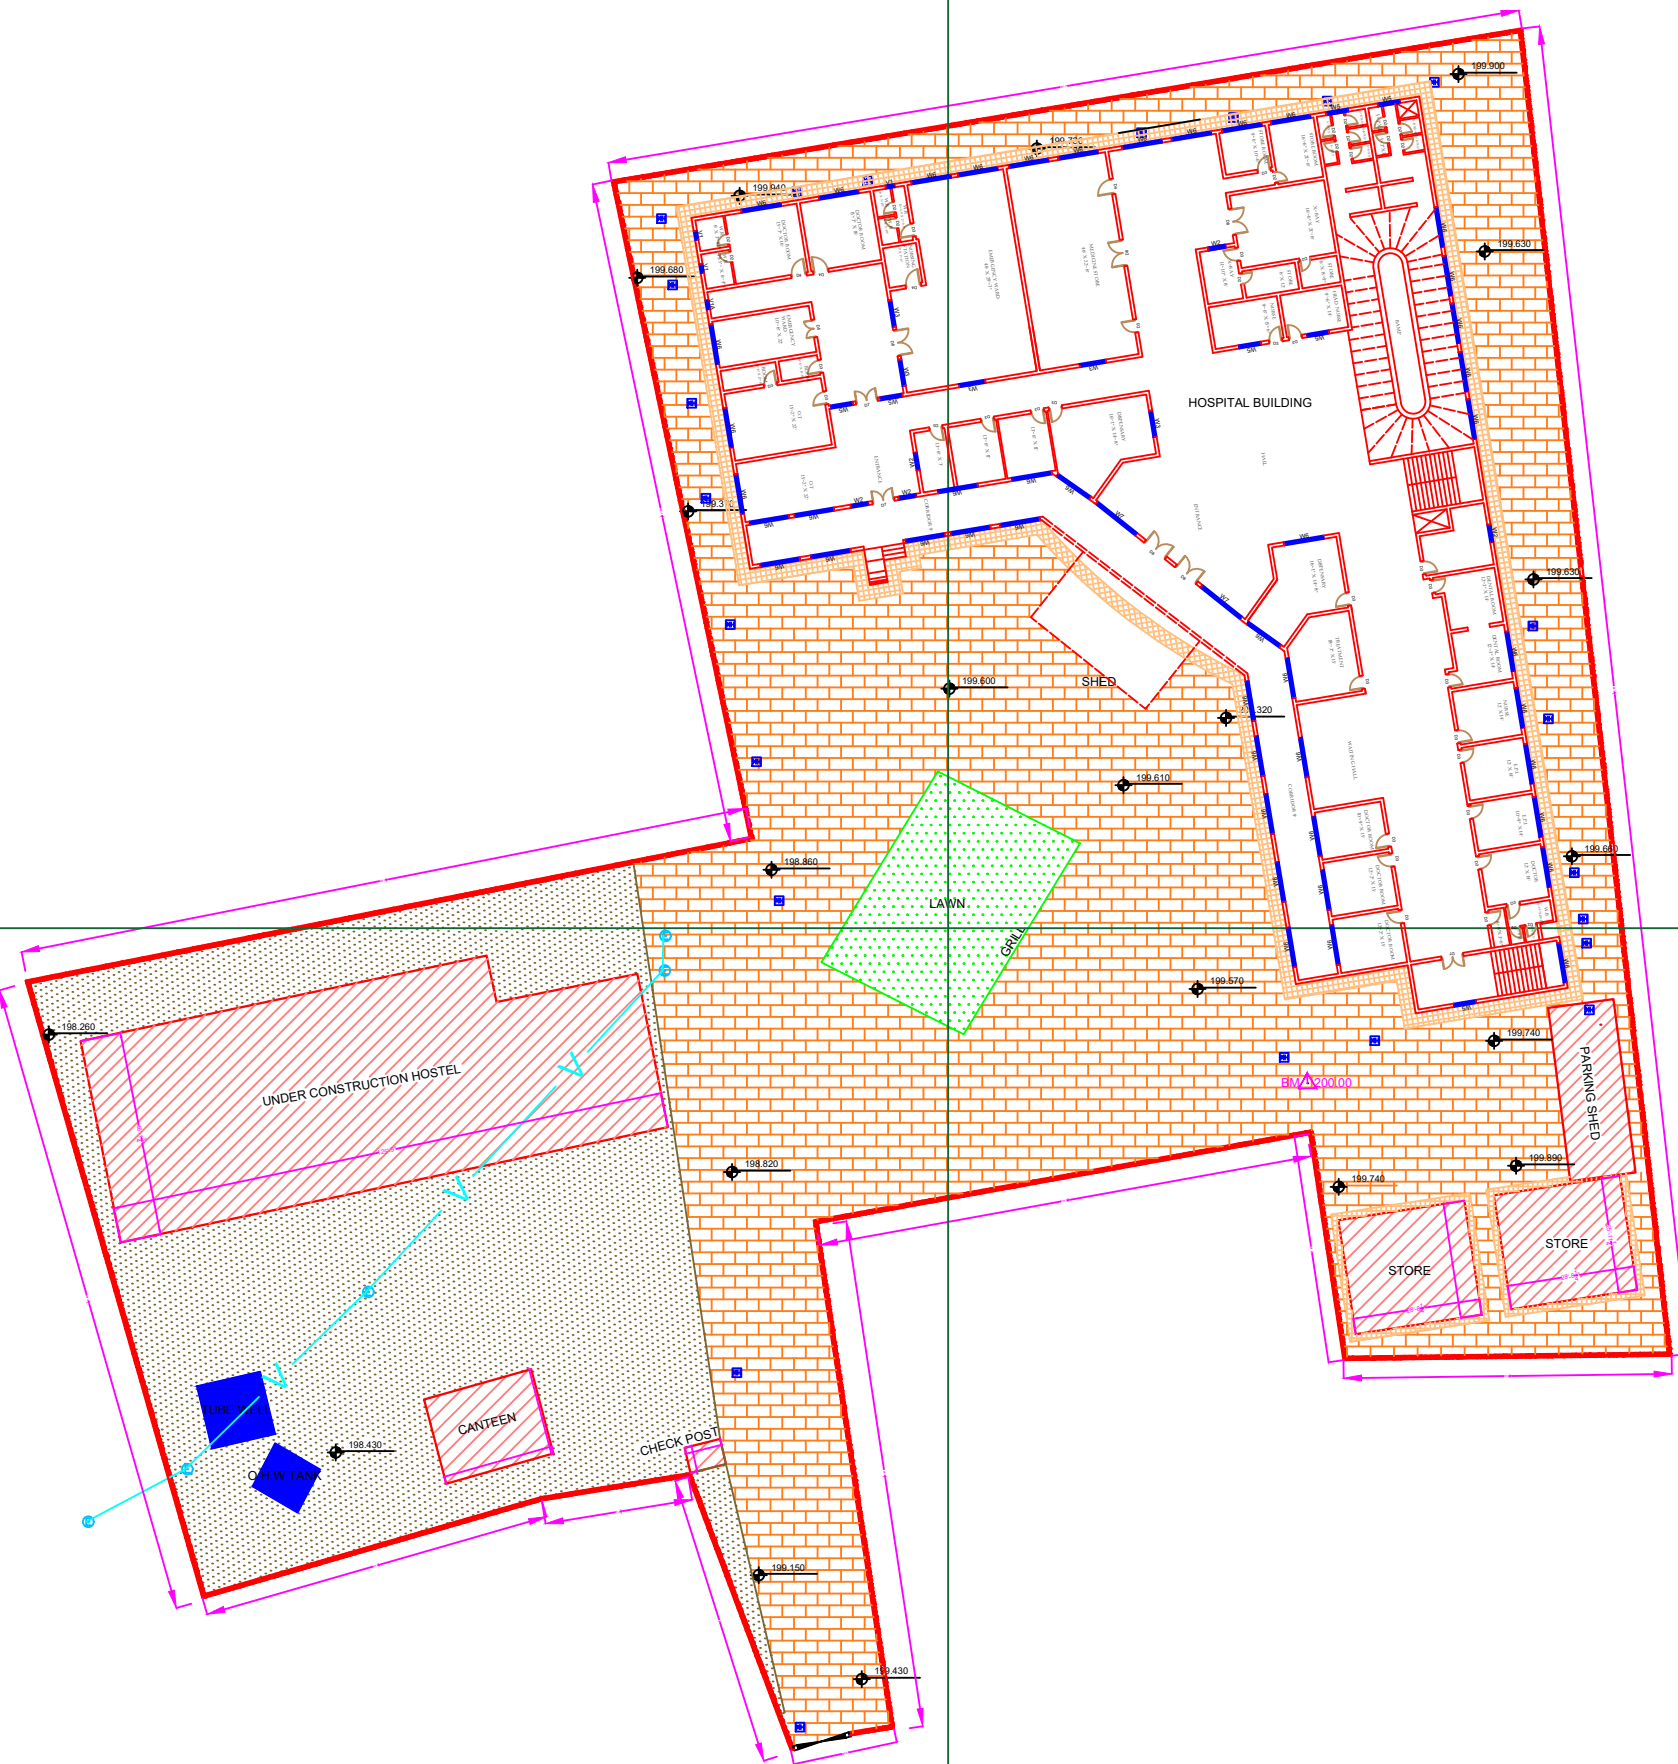


**Legends:**

Residential Area	
Road	
Wall	
Power Line	
OHT	
Tree	
Man Hole	
Tube Well	
Light Pole	
Lawns	
Earthen Areas	
Asphalts Roads	
Tough Pavers	
P.C.C / Plinth Protection	
Boundary Wall	
Brick Pavers / Soling	
Drain	
Tap	
Hand Pump	
Air Conditioner	
Tube Light	
Fan	
Roof Light	
Bulb	

AREA	
AREA WITHIN BOUNDARY WALL	75074.850 Sft
AREA OF CLINICAL BLOCK	61286.133 Sft
PLINTH AREA OF BLOCK	20428.711 Sft

OPENING SCHEDULE OF DOORS AND WINDOWS					
DOORS	WIDTH	HEIGHT	WINDOWS	WIDTH	HEIGHT
D1	2'-0"	7'-0"	W1	3'-0"	5'-0"
D2	2'-6"	7'-0"	W2	4'-0"	4'-0"
D3	3'-0"	7'-0"	W3	6'-0"	6'-0"
D4	3'-6"	7'-0"	W4	8'-0"	8'-0"
D5	4'-0"	7'-0"	W5	5'-0"	5'-0"
D6	4'-6"	7'-0"	W6	9'-0"	8'-6"
D7	5'-0"	7'-0"	W7	11'-0"	8'-6"
D8	6'-0"	7'-0"	V1	2'-0"	2'-0"
D9	7'-0"	7'-0"	V1A	2'-0"	2'-0"

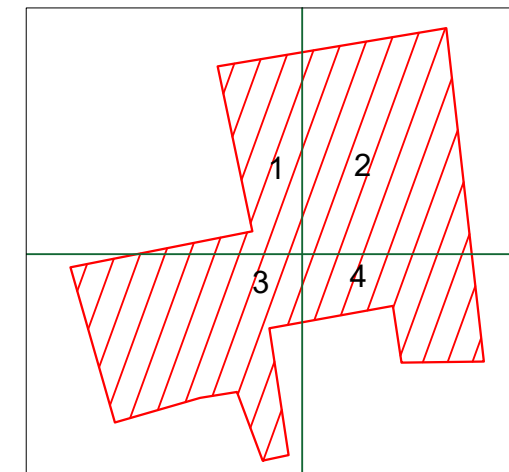

Project:  
**CAD MAPPING OF TEHSIL HEAD QUARTER HOSPITALS, PUNJAB**



Client:  GOVERNMENT OF THE PUNJAB PRIMARY & SECONDARY HEALTHCARE DEPARTMENT	Consultant:  SKAFS CONSULTANT (Pvt.) Limited ENGINEERING AND ENVIRONMENT CONSULTANT
---	--

Drawing Title:  
**THQ TALAGANG CITY HOSPITAL MASTER PLAN**

Drawing No. **SKAFS/TALAGANG-C/03**

# MASTER PLAN OF THQ HOSPITAL TALAGANG CITY

## PART 1

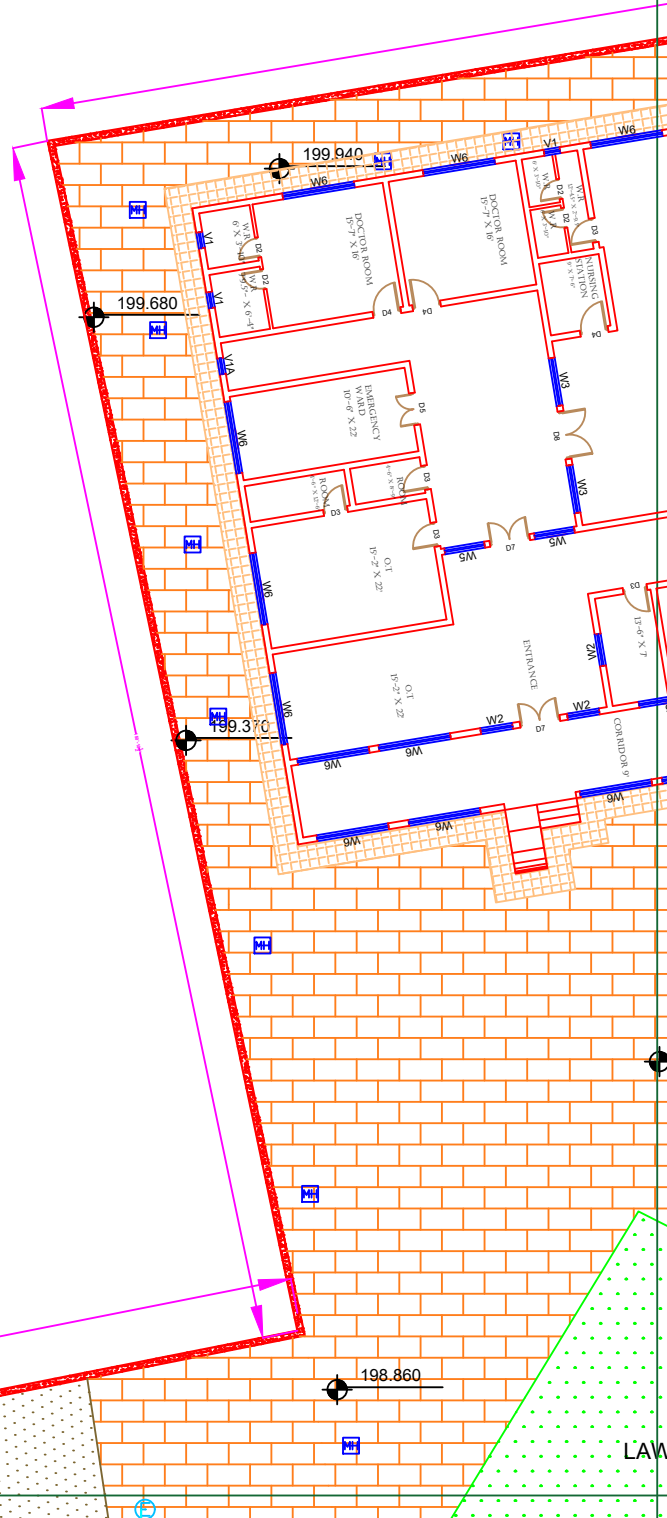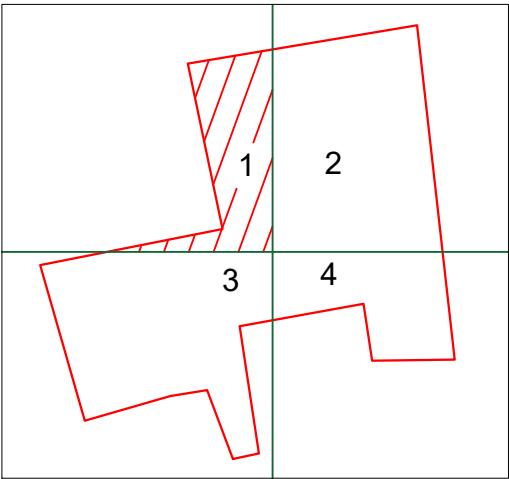

**Legends:**

Residential Area	
Road	
Wall	
Power Line	
OHT	
Tree	
Man Hole	
Tube Well	
Light Pole	
Lawns	
Earthen Areas	
Asphalts Roads	
Tough Pavers	
P.C.C / Plinth Protection	
Boundary Wall	
Brick Pavers / Soling	
Drain	
Tap	
Hand Pump	
Air Conditioner	
Tube Light	
Fan	
Roof Light	
Bulb	

AREA	
AREA WITHIN BOUNDARY WALL	75074.850 Sft
AREA OF CLINICAL BLOCK	61286.133 Sft
PLINTH AREA OF BLOCK	20428.711 Sft

OPENING SCHEDULE OF DOORS AND WINDOWS					
DOORS	WIDTH	HEIGHT	WINDOWS	WIDTH	HEIGHT
D1	2'-0"	7'-0"	W1	3'-0"	5'-0"
D2	2'-6"	7'-0"	W2	4'-0"	4'-0"
D3	3'-0"	7'-0"	W3	6'-0"	6'-0"
D4	3'-6"	7'-0"	W4	8'-0"	8'-0"
D5	4'-0"	7'-0"	W5	5'-0"	5'-0"
D6	4'-6"	7'-0"	W6	9'-0"	8'-6"
D7	5'-0"	7'-0"	W7	11'-0"	8'-6"
D8	6'-0"	7'-0"	V1	2'-0"	2'-0"
D9	7'-0"	7'-0"	V1A	2'-0"	2'-0"

Project:  
**CAD MAPPING OF TEHSIL HEAD QUARTER HOSPITALS, PUNJAB**



Client:  GOVERNMENT OF THE PUNJAB PRIMARY & SECONDARY HEALTHCARE DEPARTMENT	Consultant:  SKAFS CONSULTANT (Pvt.) Limited ENGINEERING AND ENVIRONMENT CONSULTANT
---	--

Drawing Title:  
**THQ TALAGANG CITY HOSPITAL MASTER PLAN PART 1**

Drawing No.  
**SKAFS/TALAGANG-C04**

# MASTER PLAN OF THQ HOSPITAL TALAGANG CITY

## PART 2

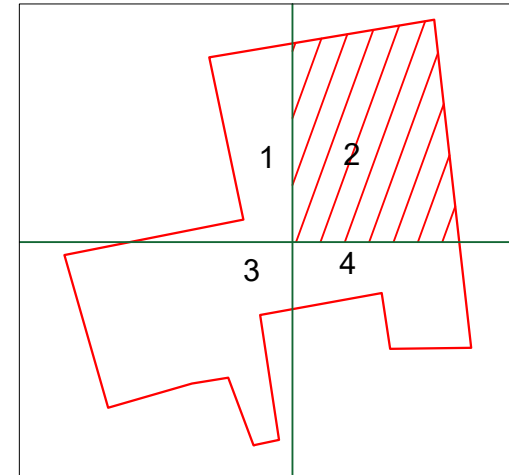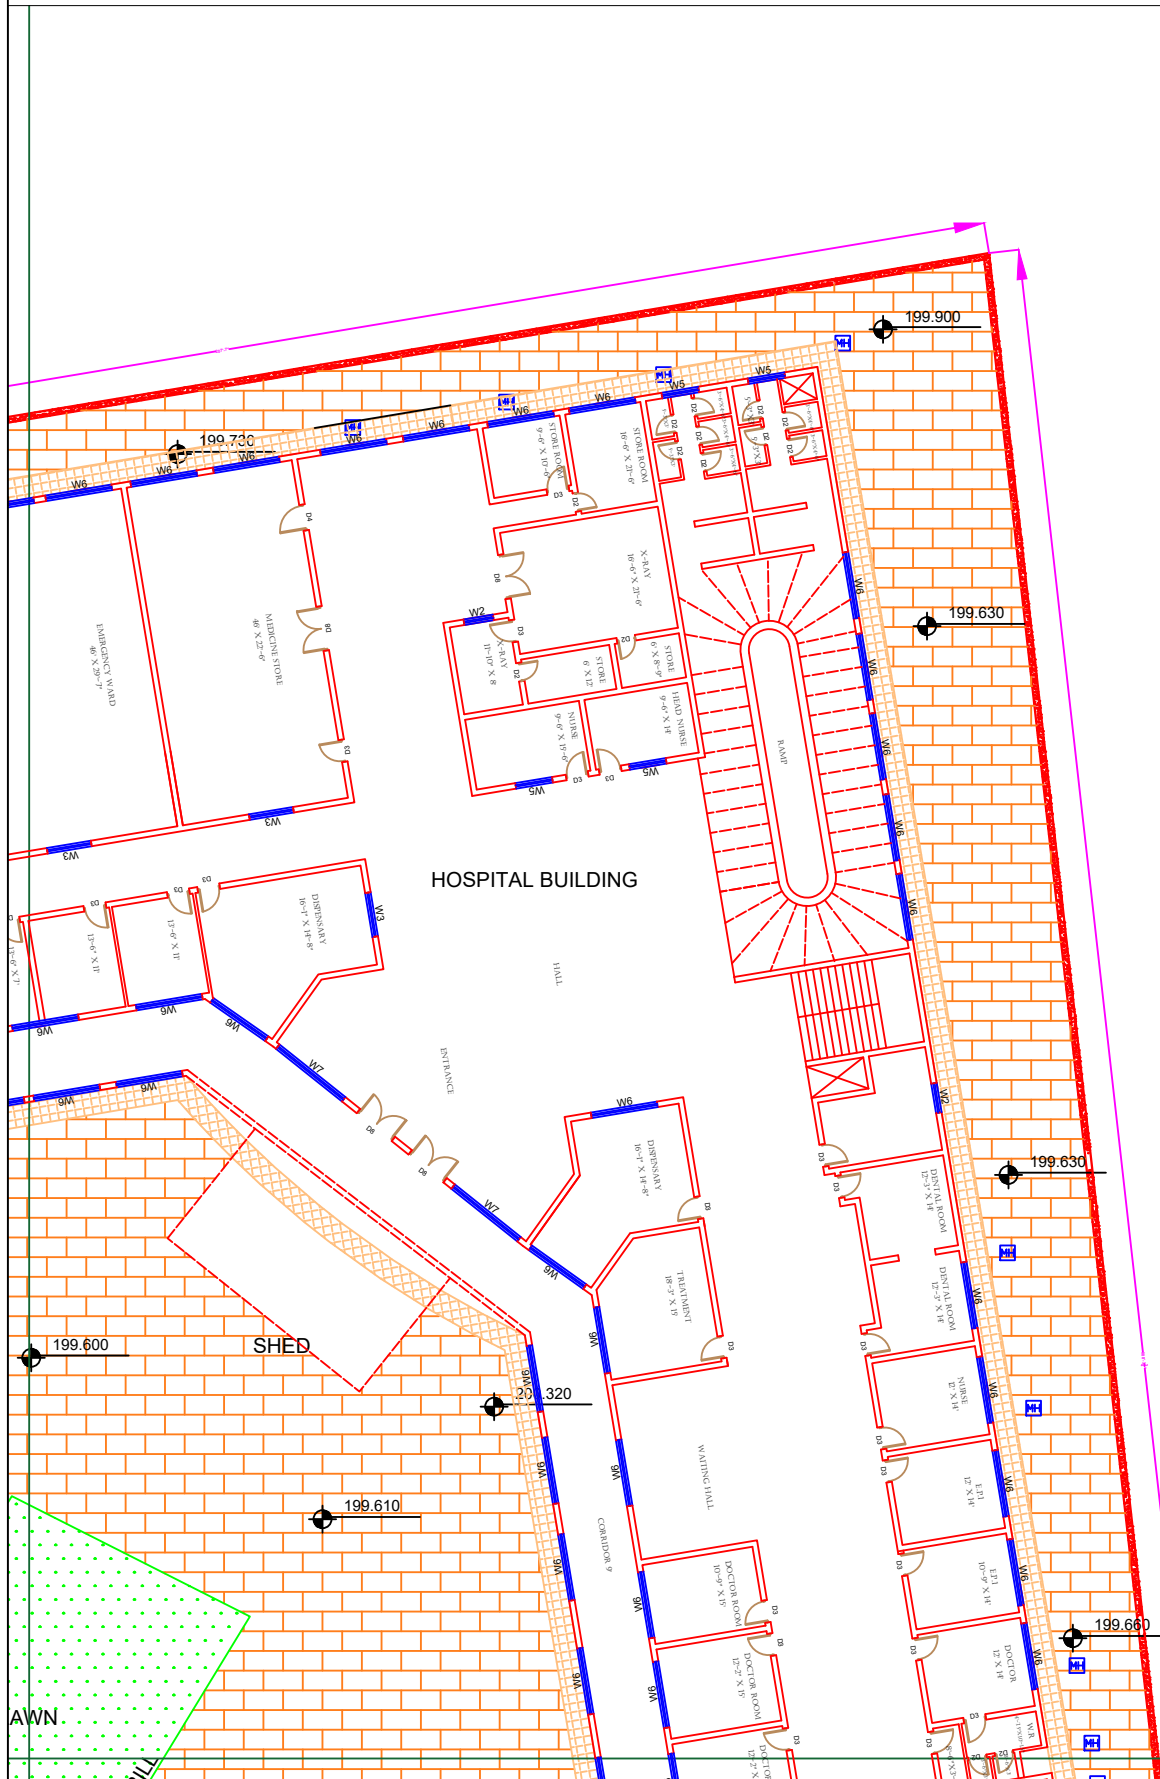

### Legends:

Residential Area	
Road	
Wall	
Power Line	
OHT	
Tree	
Man Hole	
Tube Well	
Light Pole	
Lawns	
Earthen Areas	
Asphalts Roads	
Tough Pavers	
P.C.C / Plinth Protection	
Boundary Wall	
Brick Pavers / Soling	
Drain	
Tap	
Hand Pump	
Air Conditioner	
Tube Light	
Fan	
Roof Light	
Bulb	

AREA	
AREA WITHIN BOUNDARY WALL	75074.850 Sft
AREA OF CLINICAL BLOCK	61286.133 Sft
PLINTH AREA OF BLOCK	20428.711 Sft

OPENING SCHEDULE OF DOORS AND WINDOWS					
DOORS	WIDTH	HEIGHT	WINDOWS	WIDTH	HEIGHT
D1	2'-0"	7'-0"	W1	3'-0"	5'-0"
D2	2'-6"	7'-0"	W2	4'-0"	4'-0"
D3	3'-0"	7'-0"	W3	6'-0"	6'-0"
D4	3'-6"	7'-0"	W4	8'-0"	8'-0"
D5	4'-0"	7'-0"	W5	5'-0"	5'-0"
D6	4'-6"	7'-0"	W6	9'-0"	8'-6"
D7	5'-0"	7'-0"	W7	11'-0"	8'-6"
D8	6'-0"	7'-0"	V1	2'-0"	2'-0"
D9	7'-0"	7'-0"	V1A	2'-0"	2'-0"



Project:  
**CAD MAPPING OF TEHSIL HEAD QUARTER HOSPITALS, PUNJAB**

Client:  GOVERNMENT OF THE PUNJAB PRIMARY & SECONDARY HEALTHCARE DEPARTMENT	Consultant:  SKAFS CONSULTANT (Pvt.) Limited ENGINEERING AND ENVIRONMENT CONSULTANT
---	--

Drawing Title:  
**THQ TALAGANG CITY HOSPITAL MASTER PLAN PART 2**  
 Drawing No. **SKAFS/TALAGANG-C05**

# MASTER PLAN OF THQ HOSPITAL TALAGANG CITY

## PART 3

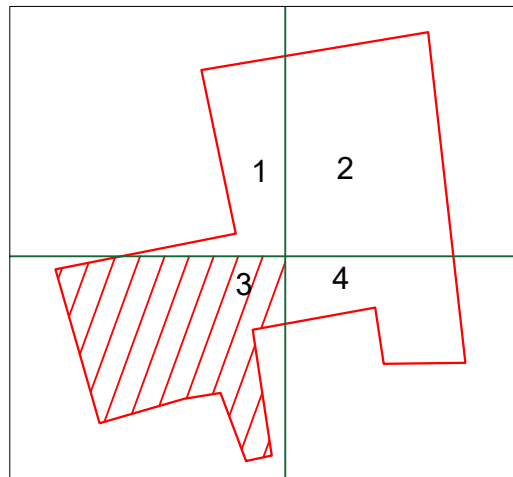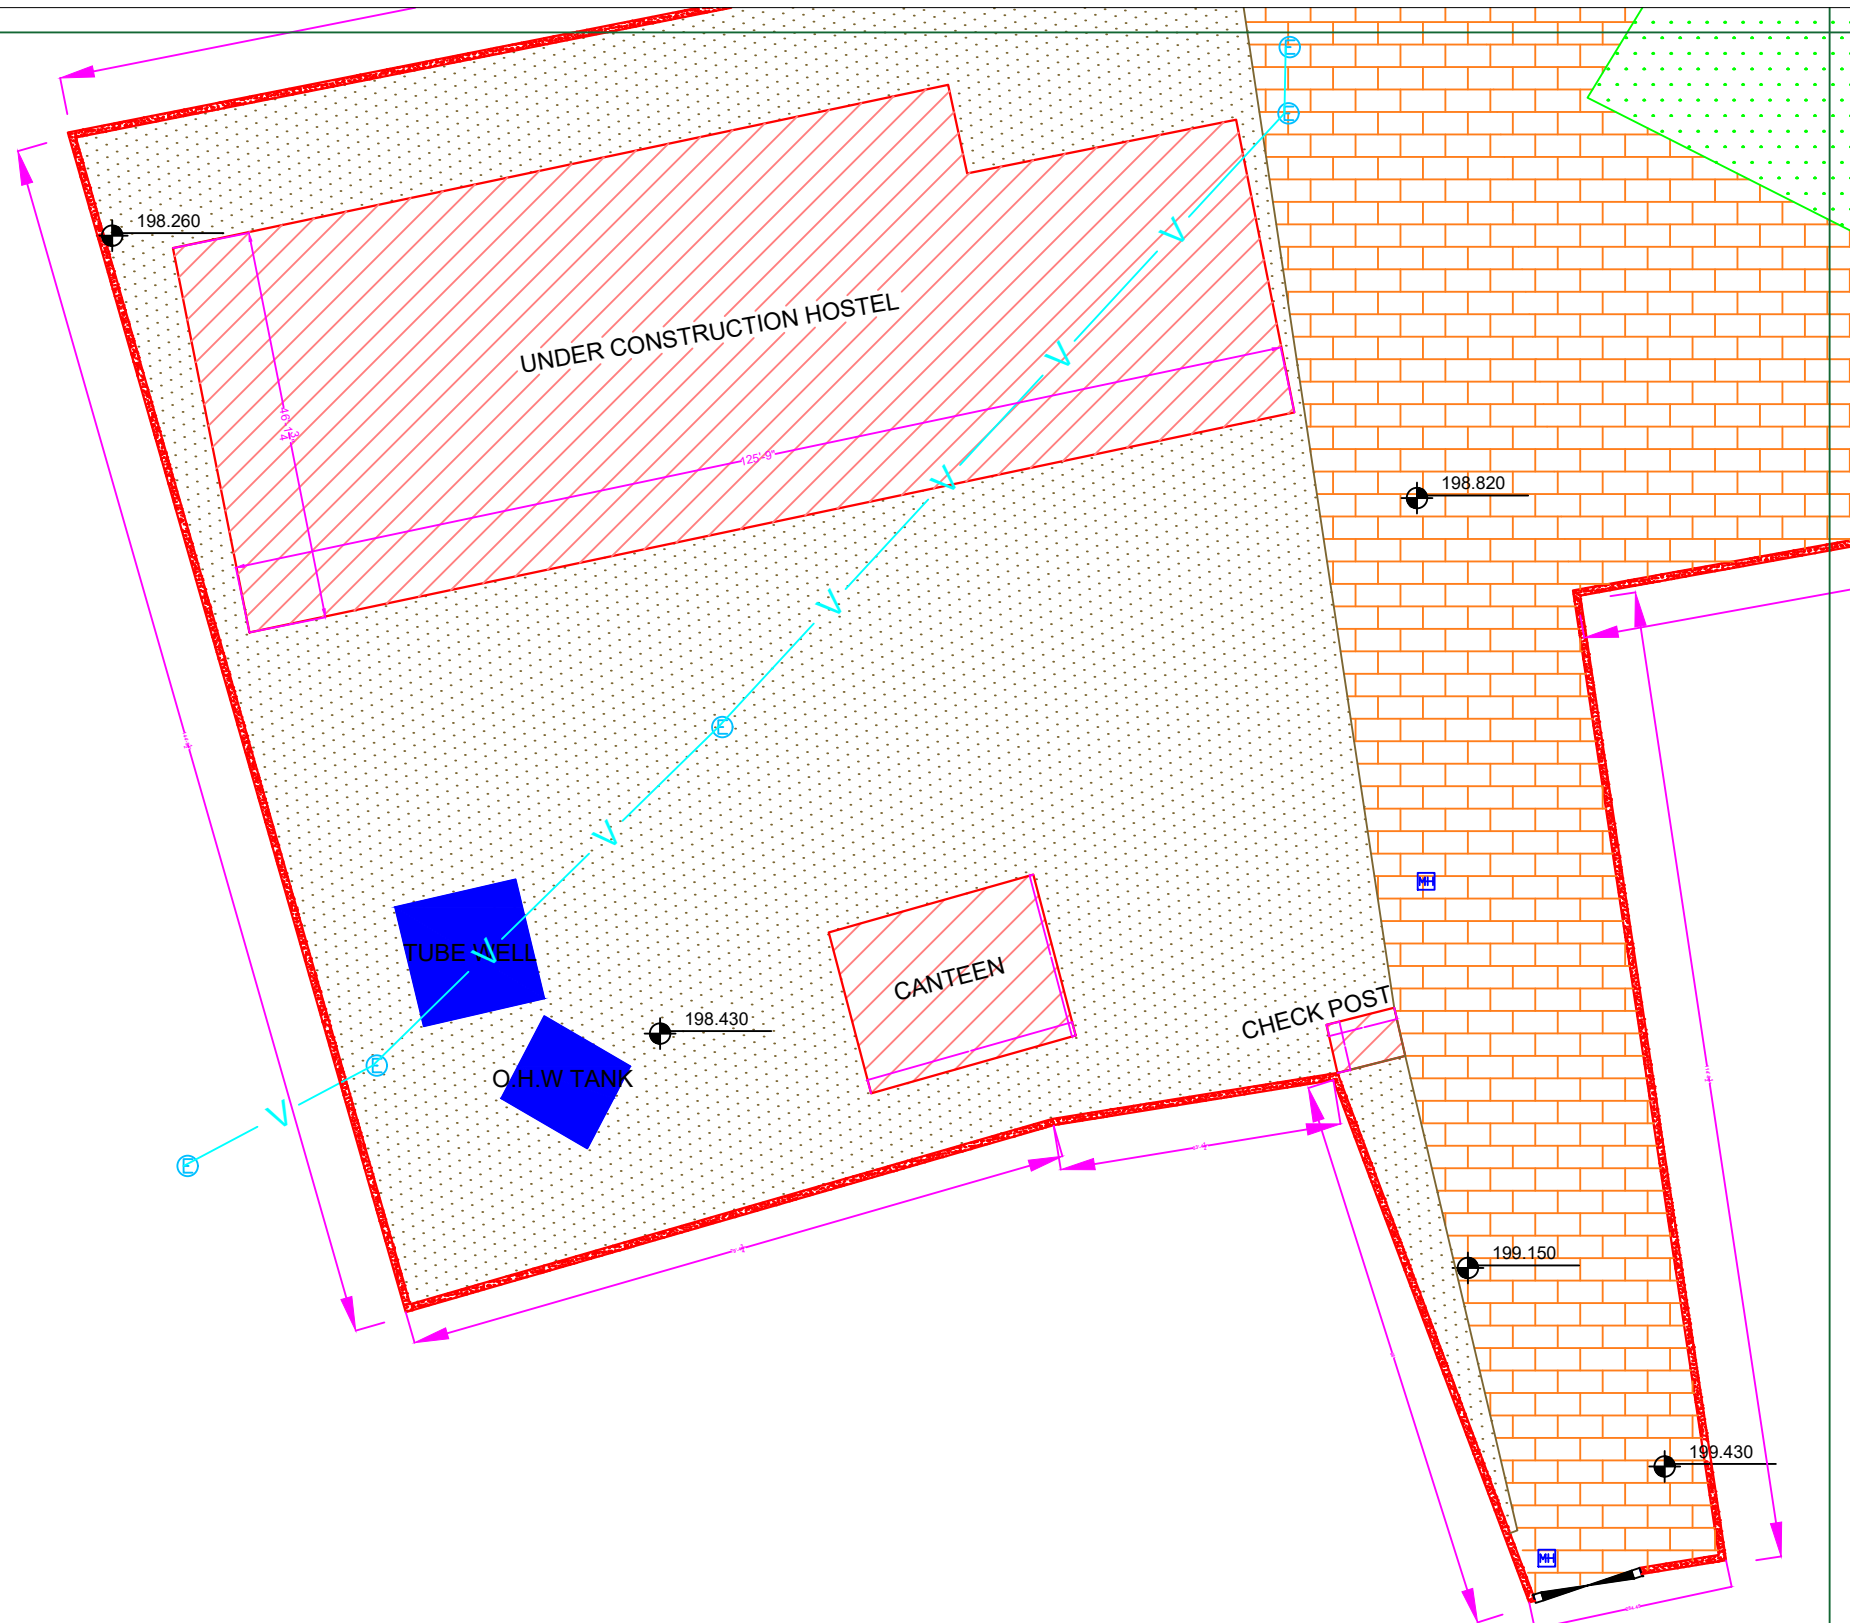

### Legends:

Residential Area	
Road	
Wall	
Power Line	
OHT	
Tree	
Man Hole	
Tube Well	
Light Pole	
Lawns	
Earthen Areas	
Asphalts Roads	
Tough Pavers	
P.C.C / Plinth Protection	
Boundary Wall	
Brick Pavers / Soling	
Drain	
Tap	
Hand Pump	
Air Conditioner	
Tube Light	
Fan	
Roof Light	
Bulb	

AREA	
AREA WITHIN BOUNDARY WALL	75074.850 Sft
AREA OF CLINICAL BLOCK	61286.133 Sft
PLINTH AREA OF BLOCK	20428.711 Sft

OPENING SCHEDULE OF DOORS AND WINDOWS					
DOORS	WIDTH	HEIGHT	WINDOWS	WIDTH	HEIGHT
D1	2'-0"	7'-0"	W1	3'-0"	5'-0"
D2	2'-6"	7'-0"	W2	4'-0"	4'-0"
D3	3'-0"	7'-0"	W3	6'-0"	6'-0"
D4	3'-6"	7'-0"	W4	8'-0"	8'-0"
D5	4'-0"	7'-0"	W5	5'-0"	5'-0"
D6	4'-6"	7'-0"	W6	9'-0"	8'-6"
D7	5'-0"	7'-0"	W7	11'-0"	8'-6"
D8	6'-0"	7'-0"	V1	2'-0"	2'-0"
D9	7'-0"	7'-0"	V1A	2'-0"	2'-0"

Project:  
**CAD MAPPING OF TEHSIL HEAD QUARTER HOSPITALS, PUNJAB**

Client:  GOVERNMENT OF THE PUNJAB PRIMARY & SECONDARY HEALTHCARE DEPARTMENT	Consultant:  SKAFS CONSULTANT (Pvt.) Limited ENGINEERING AND ENVIRONMENT CONSULTANT
---	--


Drawing Title:  
**THQ TALAGANG CITY HOSPITAL MASTER PLAN PART 3**

Drawing No. **SKAFS/TALAGANG-C06**



# MASTER PLAN OF THQ HOSPITAL TALAGANG CITY

## PART 4

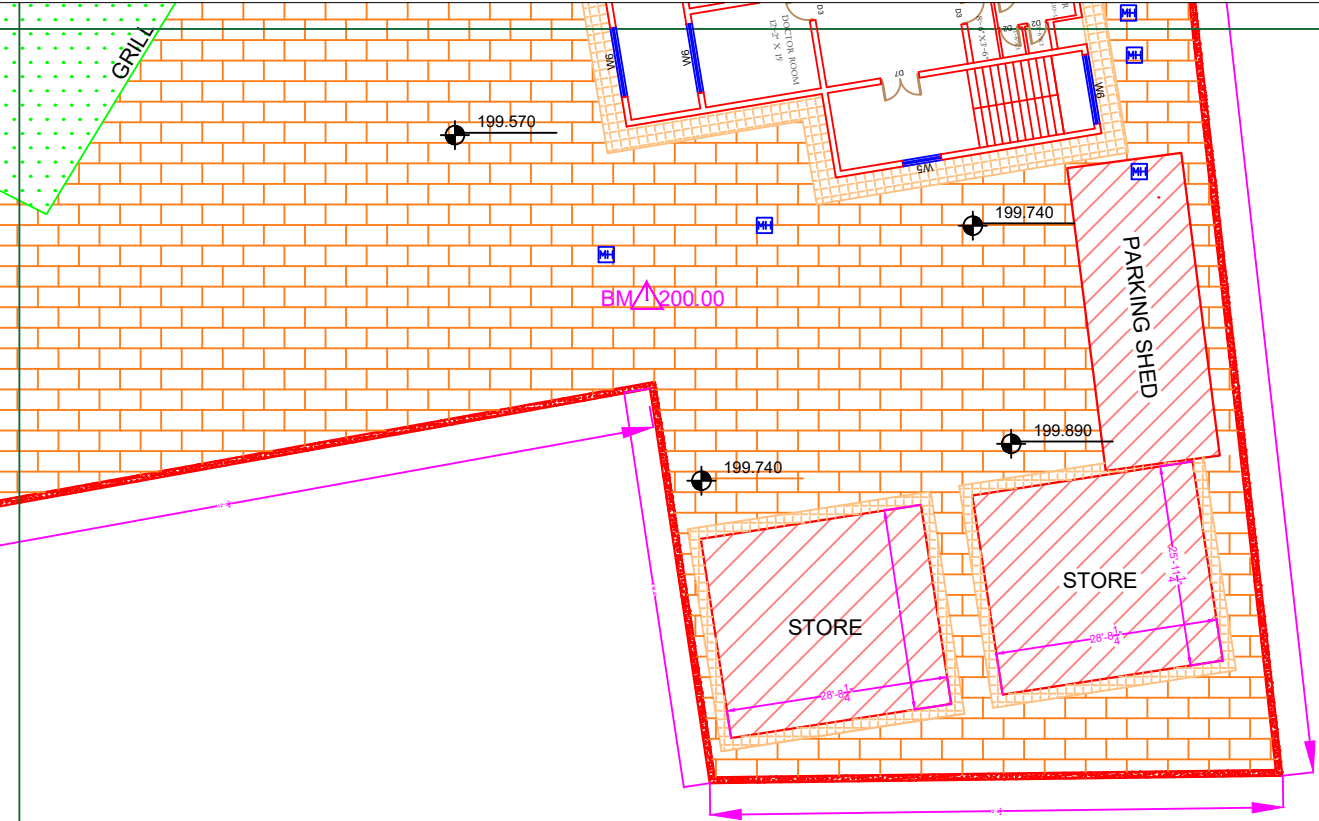


**Legends:**

Residential Area	
Road	
Wall	
Power Line	
OHT	
Tree	
Man Hole	
Tube Well	
Light Pole	
Lawns	
Earthen Areas	
Asphalts Roads	
Tough Pavers	
P.C.C / Plinth Protection	
Boundary Wall	
Brick Pavers / Soling	
Drain	
Tap	
Hand Pump	
Air Conditioner	
Tube Light	
Fan	
Roof Light	
Bulb	

AREA	
AREA WITHIN BOUNDARY WALL	75074.850 Sft
AREA OF CLINICAL BLOCK	61286.133 Sft
PLINTH AREA OF BLOCK	20428.711 Sft

OPENING SCHEDULE OF DOORS AND WINDOWS					
DOORS	WIDTH	HEIGHT	WINDOWS	WIDTH	HEIGHT
D1	2'-0"	7'-0"	W1	3'-0"	5'-0"
D2	2'-6"	7'-0"	W2	4'-0"	4'-0"
D3	3'-0"	7'-0"	W3	6'-0"	6'-0"
D4	3'-6"	7'-0"	W4	8'-0"	8'-0"
D5	4'-0"	7'-0"	W5	5'-0"	5'-0"
D6	4'-6"	7'-0"	W6	9'-0"	8'-6"
D7	5'-0"	7'-0"	W7	11'-0"	8'-6"
D8	6'-0"	7'-0"	V1	2'-0"	2'-0"
D9	7'-0"	7'-0"	V1A	2'-0"	2'-0"

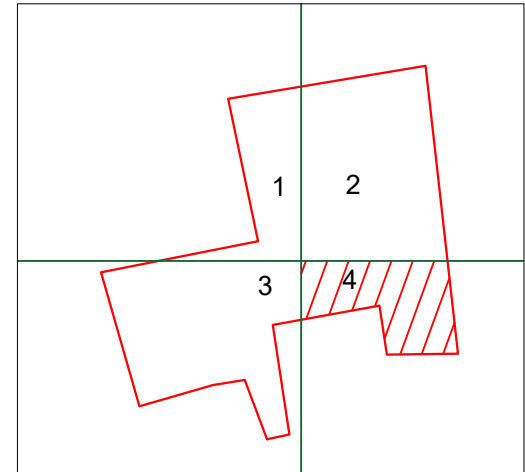

Project:  
**CAD MAPPING OF TEHSIL HEAD QUARTER HOSPITALS, PUNJAB**

Client:  GOVERNMENT OF THE PUNJAB PRIMARY & SECONDARY HEALTHCARE DEPARTMENT	Consultant:  SKAFS CONSULTANT (Pvt.) Limited ENGINEERING AND ENVIRONMENT CONSULTANT
---	--

Drawing Title:  
**THQ TALAGANG CITY HOSPITAL MASTER PLAN PART 4**


Drawing No. **SKAFS/TALAGANG-C07**

# CLINICAL BLOCK OF THQ HOSPITAL TALAGANG CITY

## GROUND FLOOR

PART 1

PART 2

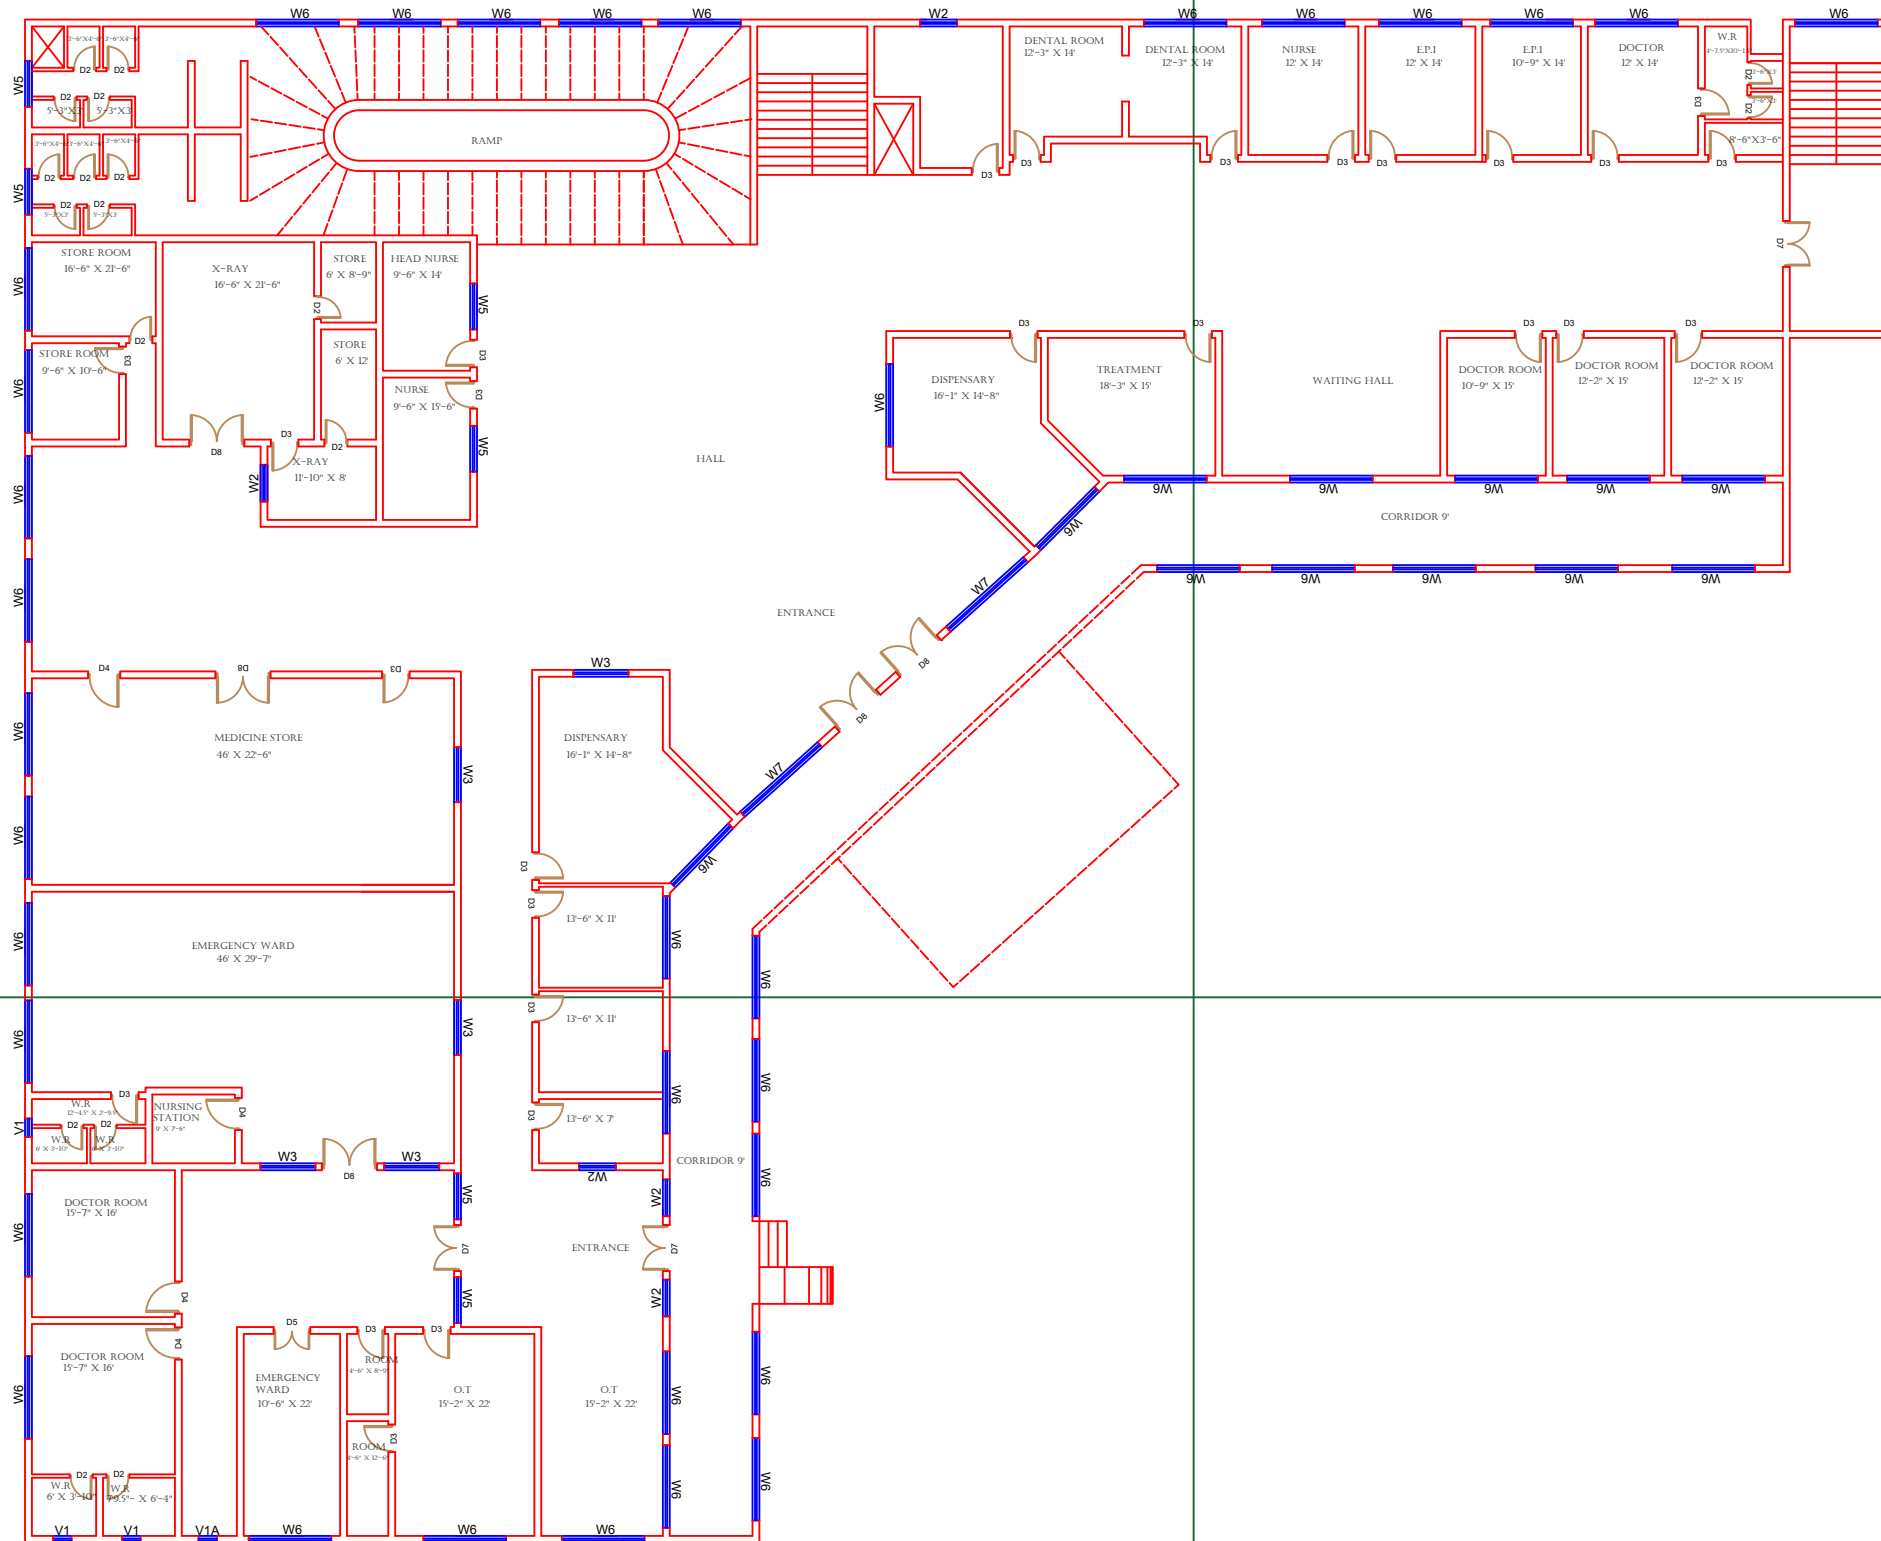

PART 3

### Legends:

Residential Area	
Road	
Wall	
Power Line	
OHT	
Tree	
Man Hole	
Tube Well	
Light Pole	
Lawns	
Earthen Areas	
Asphalts Roads	
Tough Pavers	
P.C.C / Plinth Protection	
Boundary Wall	
Brick Pavers / Soling	
Drain	
Tap	
Hand Pump	
Air Conditioner	
Tube Light	
Fan	
Roof Light	
Bulb	

AREA	
AREA WITHIN BOUNDARY WALL	75074.850 Sft
AREA OF CLINICAL BLOCK	61286.133 Sft
PLINTH AREA OF BLOCK	20428.711 Sft

OPENING SCHEDULE OF DOORS AND WINDOWS					
DOORS	WIDTH	HEIGHT	WINDOWS	WIDTH	HEIGHT
D1	2'-0"	7'-0"	W1	3'-0"	5'-0"
D2	2'-6"	7'-0"	W2	4'-0"	4'-0"
D3	3'-0"	7'-0"	W3	6'-0"	6'-0"
D4	3'-6"	7'-0"	W4	8'-0"	8'-0"
D5	4'-0"	7'-0"	W5	5'-0"	5'-0"
D6	4'-6"	7'-0"	W6	9'-0"	8'-6"
D7	5'-0"	7'-0"	W7	11'-0"	8'-6"
D8	6'-0"	7'-0"	V1	2'-0"	2'-0"
D9	7'-0"	7'-0"	V1A	2'-0"	2'-0"

Project:  
**CAD MAPPING OF TEHSIL HEAD QUARTER HOSPITALS, PUNJAB**


Client:  GOVERNMENT OF THE PUNJAB PRIMARY & SECONDARY HEALTHCARE DEPARTMENT	Consultant:  SKAFS CONSULTANT (Pvt.) Limited ENGINEERING AND ENVIRONMENT CONSULTANT
---	--

Drawing Title:  
**THQ TALAGANG CITY HOSPITAL CLINICAL BLOCK PLAN**

Drawing No.  
**SKAFS/TALAGANG-C08**

# CLINICAL BLOCK OF THQ HOSPITAL TALAGANG CITY

## GROUND FLOOR PART 1

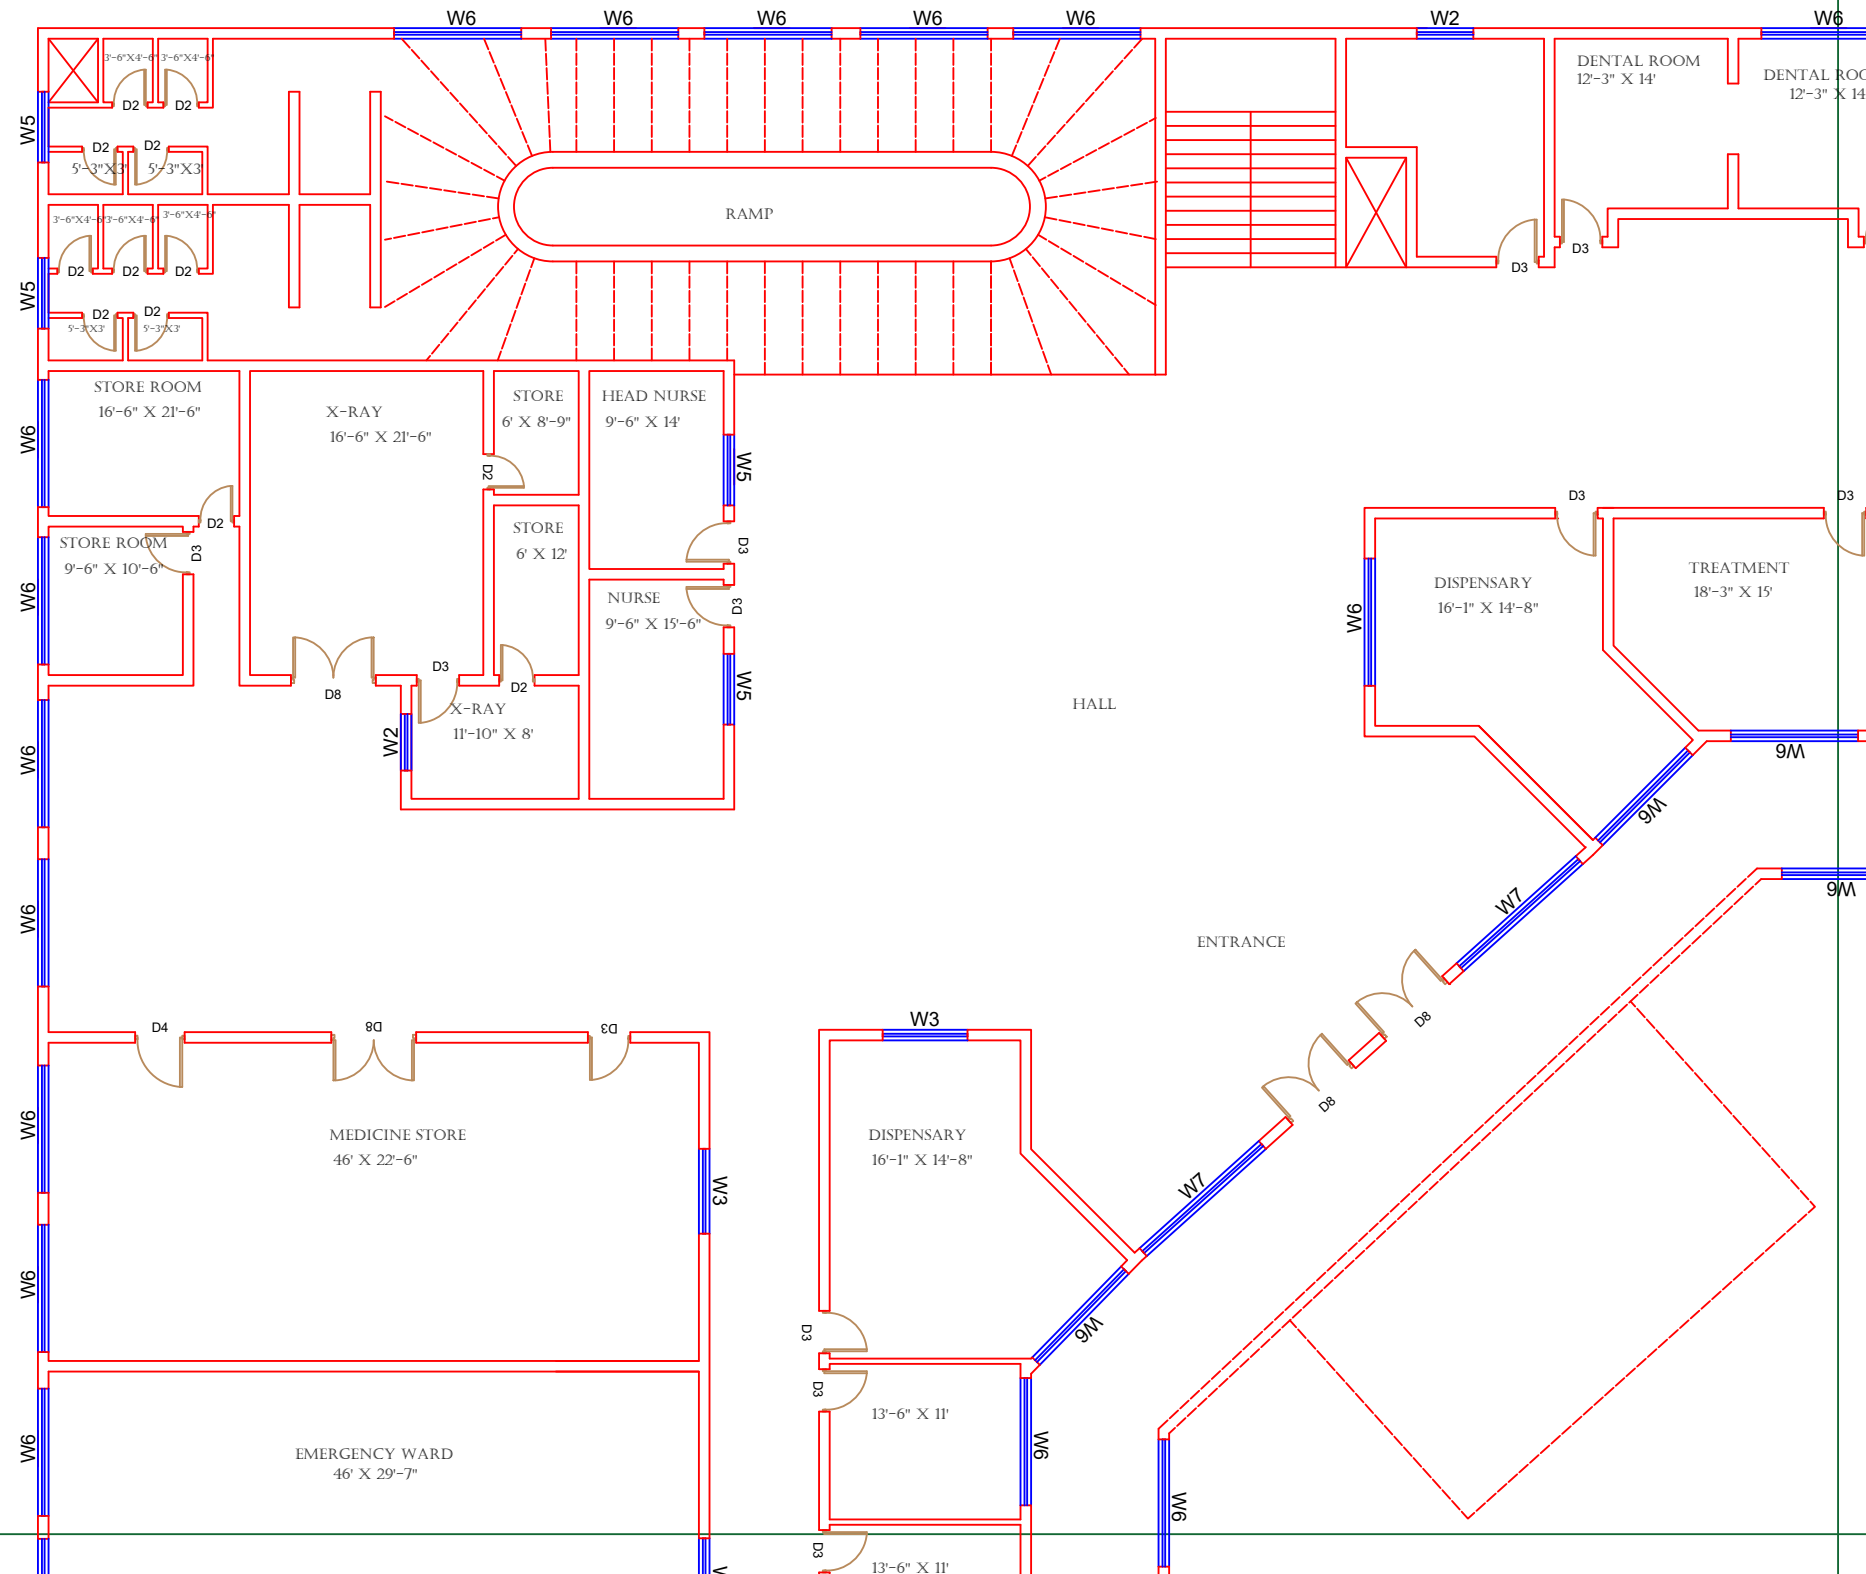

### Legends:

Residential Area	
Road	
Wall	
Power Line	
OHT	
Tree	
Man Hole	
Tube Well	
Light Pole	
Lawns	
Earthen Areas	
Asphalts Roads	
Tough Pavers	
P.C.C / Plinth Protection	
Boundary Wall	
Brick Pavers / Soling	
Drain	
Tap	
Hand Pump	
Air Conditioner	
Tube Light	
Fan	
Roof Light	
Bulb	

AREA	
AREA WITHIN BOUNDARY WALL	75074.850 Sft
AREA OF CLINICAL BLOCK	61286.133 Sft
PLINTH AREA OF BLOCK	20428.711 Sft

OPENING SCHEDULE OF DOORS AND WINDOWS					
DOORS	WIDTH	HEIGHT	WINDOWS	WIDTH	HEIGHT
D1	2'-0"	7'-0"	W1	3'-0"	5'-0"
D2	2'-6"	7'-0"	W2	4'-0"	4'-0"
D3	3'-0"	7'-0"	W3	6'-0"	6'-0"
D4	3'-6"	7'-0"	W4	8'-0"	8'-0"
D5	4'-0"	7'-0"	W5	5'-0"	5'-0"
D6	4'-6"	7'-0"	W6	9'-0"	8'-6"
D7	5'-0"	7'-0"	W7	11'-0"	8'-6"
D8	6'-0"	7'-0"	V1	2'-0"	2'-0"
D9	7'-0"	7'-0"	V1A	2'-0"	2'-0"

Project:  
**CAD MAPPING OF TEHSIL HEAD QUARTER HOSPITALS, PUNJAB**


Client:  GOVERNMENT OF THE PUNJAB PRIMARY & SECONDARY HEALTHCARE DEPARTMENT	Consultant:  SKAFS CONSULTANT (Pvt.) Limited ENGINEERING AND ENVIRONMENT CONSULTANT
---	--

Drawing Title:  
**THQ TALAGANG CITY  
CLINICAL BLOCK PLAN (PART 1)**

Drawing No.  
**SKAFS/TALAGANG-C09**

# CLINICAL BLOCK OF THQ HOSPITAL TALAGANG CITY

## GROUND FLOOR PART 2

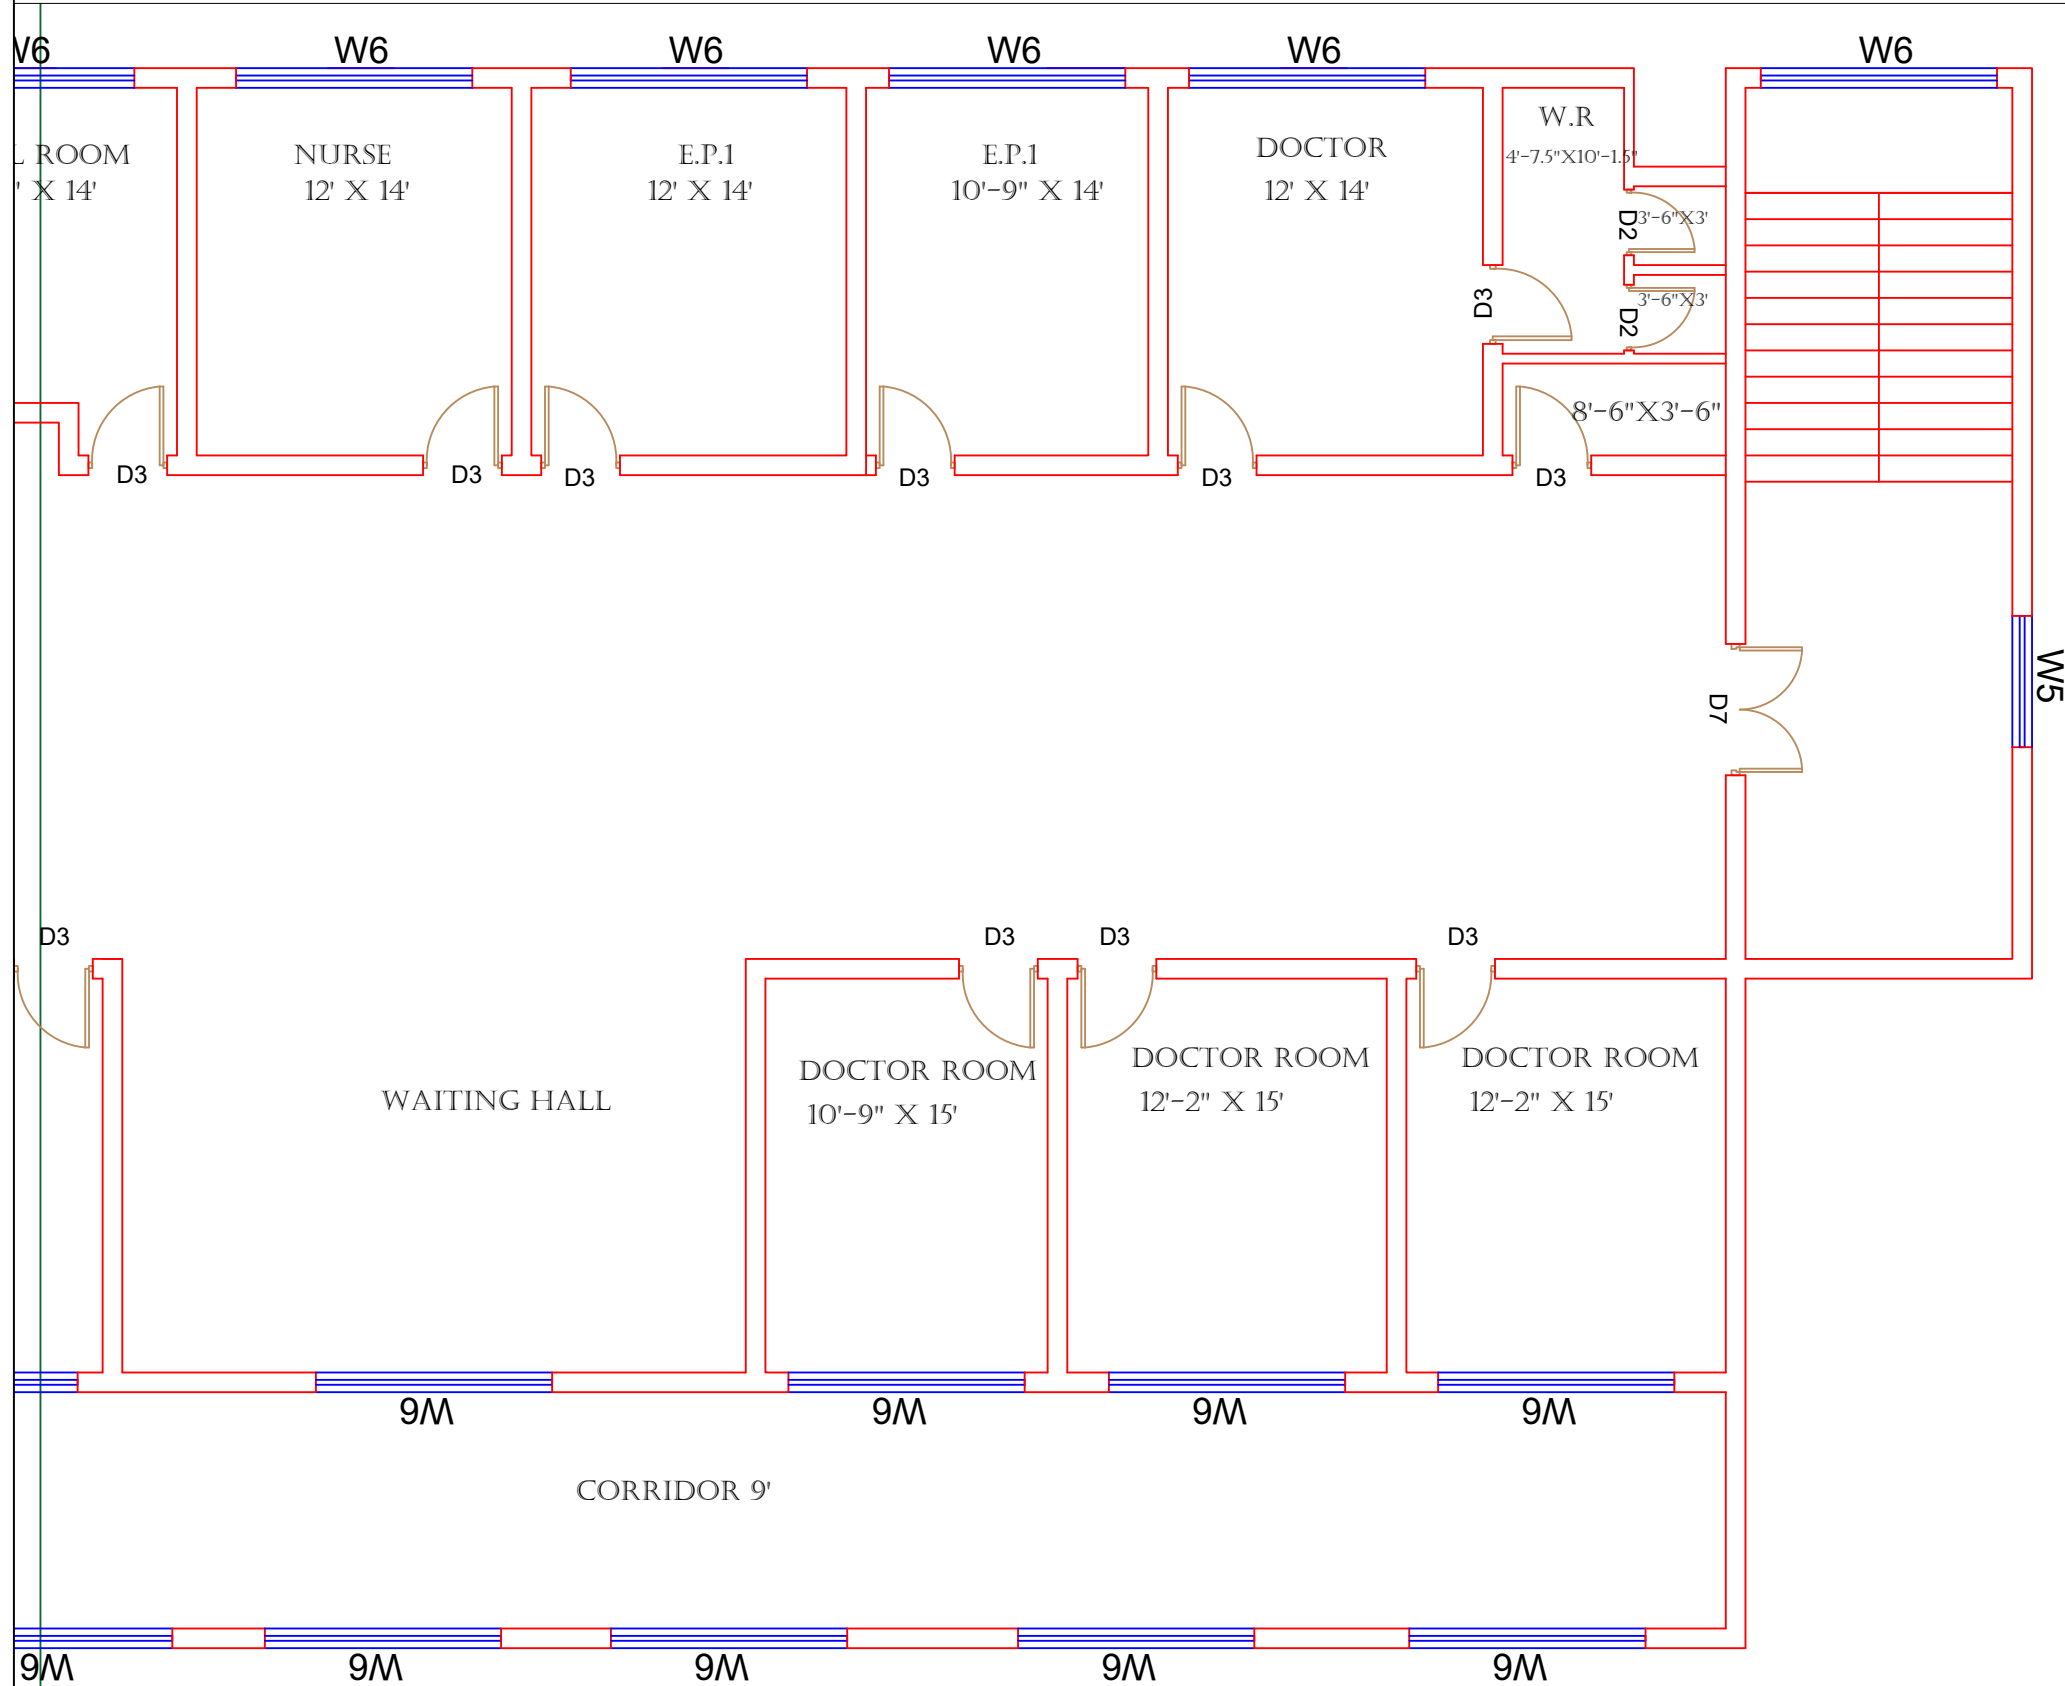

### Legends:

Residential Area	
Road	
Wall	
Power Line	
OHT	
Tree	
Man Hole	
Tube Well	
Light Pole	
Lawns	
Earthen Areas	
Asphalts Roads	
Tough Pavers	
P.C.C / Plinth Protection	
Boundary Wall	
Brick Pavers / Soling	
Drain	
Tap	
Hand Pump	
Air Conditioner	
Tube Light	
Fan	
Roof Light	
Bulb	

### AREA

AREA WITHIN BOUNDARY WALL	75074.850 Sft
AREA OF CLINICAL BLOCK	61286.133 Sft
PLINTH AREA OF BLOCK	20428.711Sft

### OPENING SCHEDULE OF DOORS AND WINDOWS

DOORS	WIDTH	HEIGHT	WINDOWS	WIDTH	HEIGHT
D1	2'-0"	7'-0"	W1	3'-0"	5'-0"
D2	2'-6"	7'-0"	W2	4'-0"	4'-0"
D3	3'-0"	7'-0"	W3	6'-0"	6'-0"
D4	3'-6"	7'-0"	W4	8'-0"	8'-0"
D5	4'-0"	7'-0"	W5	5'-0"	5'-0"
D6	4'-6"	7'-0"	W6	9'-0"	8'-6"
D7	5'-0"	7'-0"	W7	11'-0"	8'-6"
D8	6'-0"	7'-0"	V1	2'-0"	2'-0"
D9	7'-0"	7'-0"	V1A	2'-0"	2'-0"

Project:  
**CAD MAPPING OF TEHSIL HEAD QUARTER HOSPITALS, PUNJAB**

Client: GOVERNMENT OF THE PUNJAB  
PRIMARY & SECONDARY HEALTHCARE DEPARTMENT

Consultant: SKAFS CONSULTANT (Pvt.) Limited  
ENGINEERING AND ENVIRONMENT CONSULTANT


Drawing Title:  
**THQ TALAGANG CITY CLINICAL BLOCK PLAN (PART 2)**

Drawing No. **SKAFS/TALAGANG-C/10**



# CLINICAL BLOCK OF THQ HOSPITAL TALAGANG CITY

## GROUND FLOOR PART 3

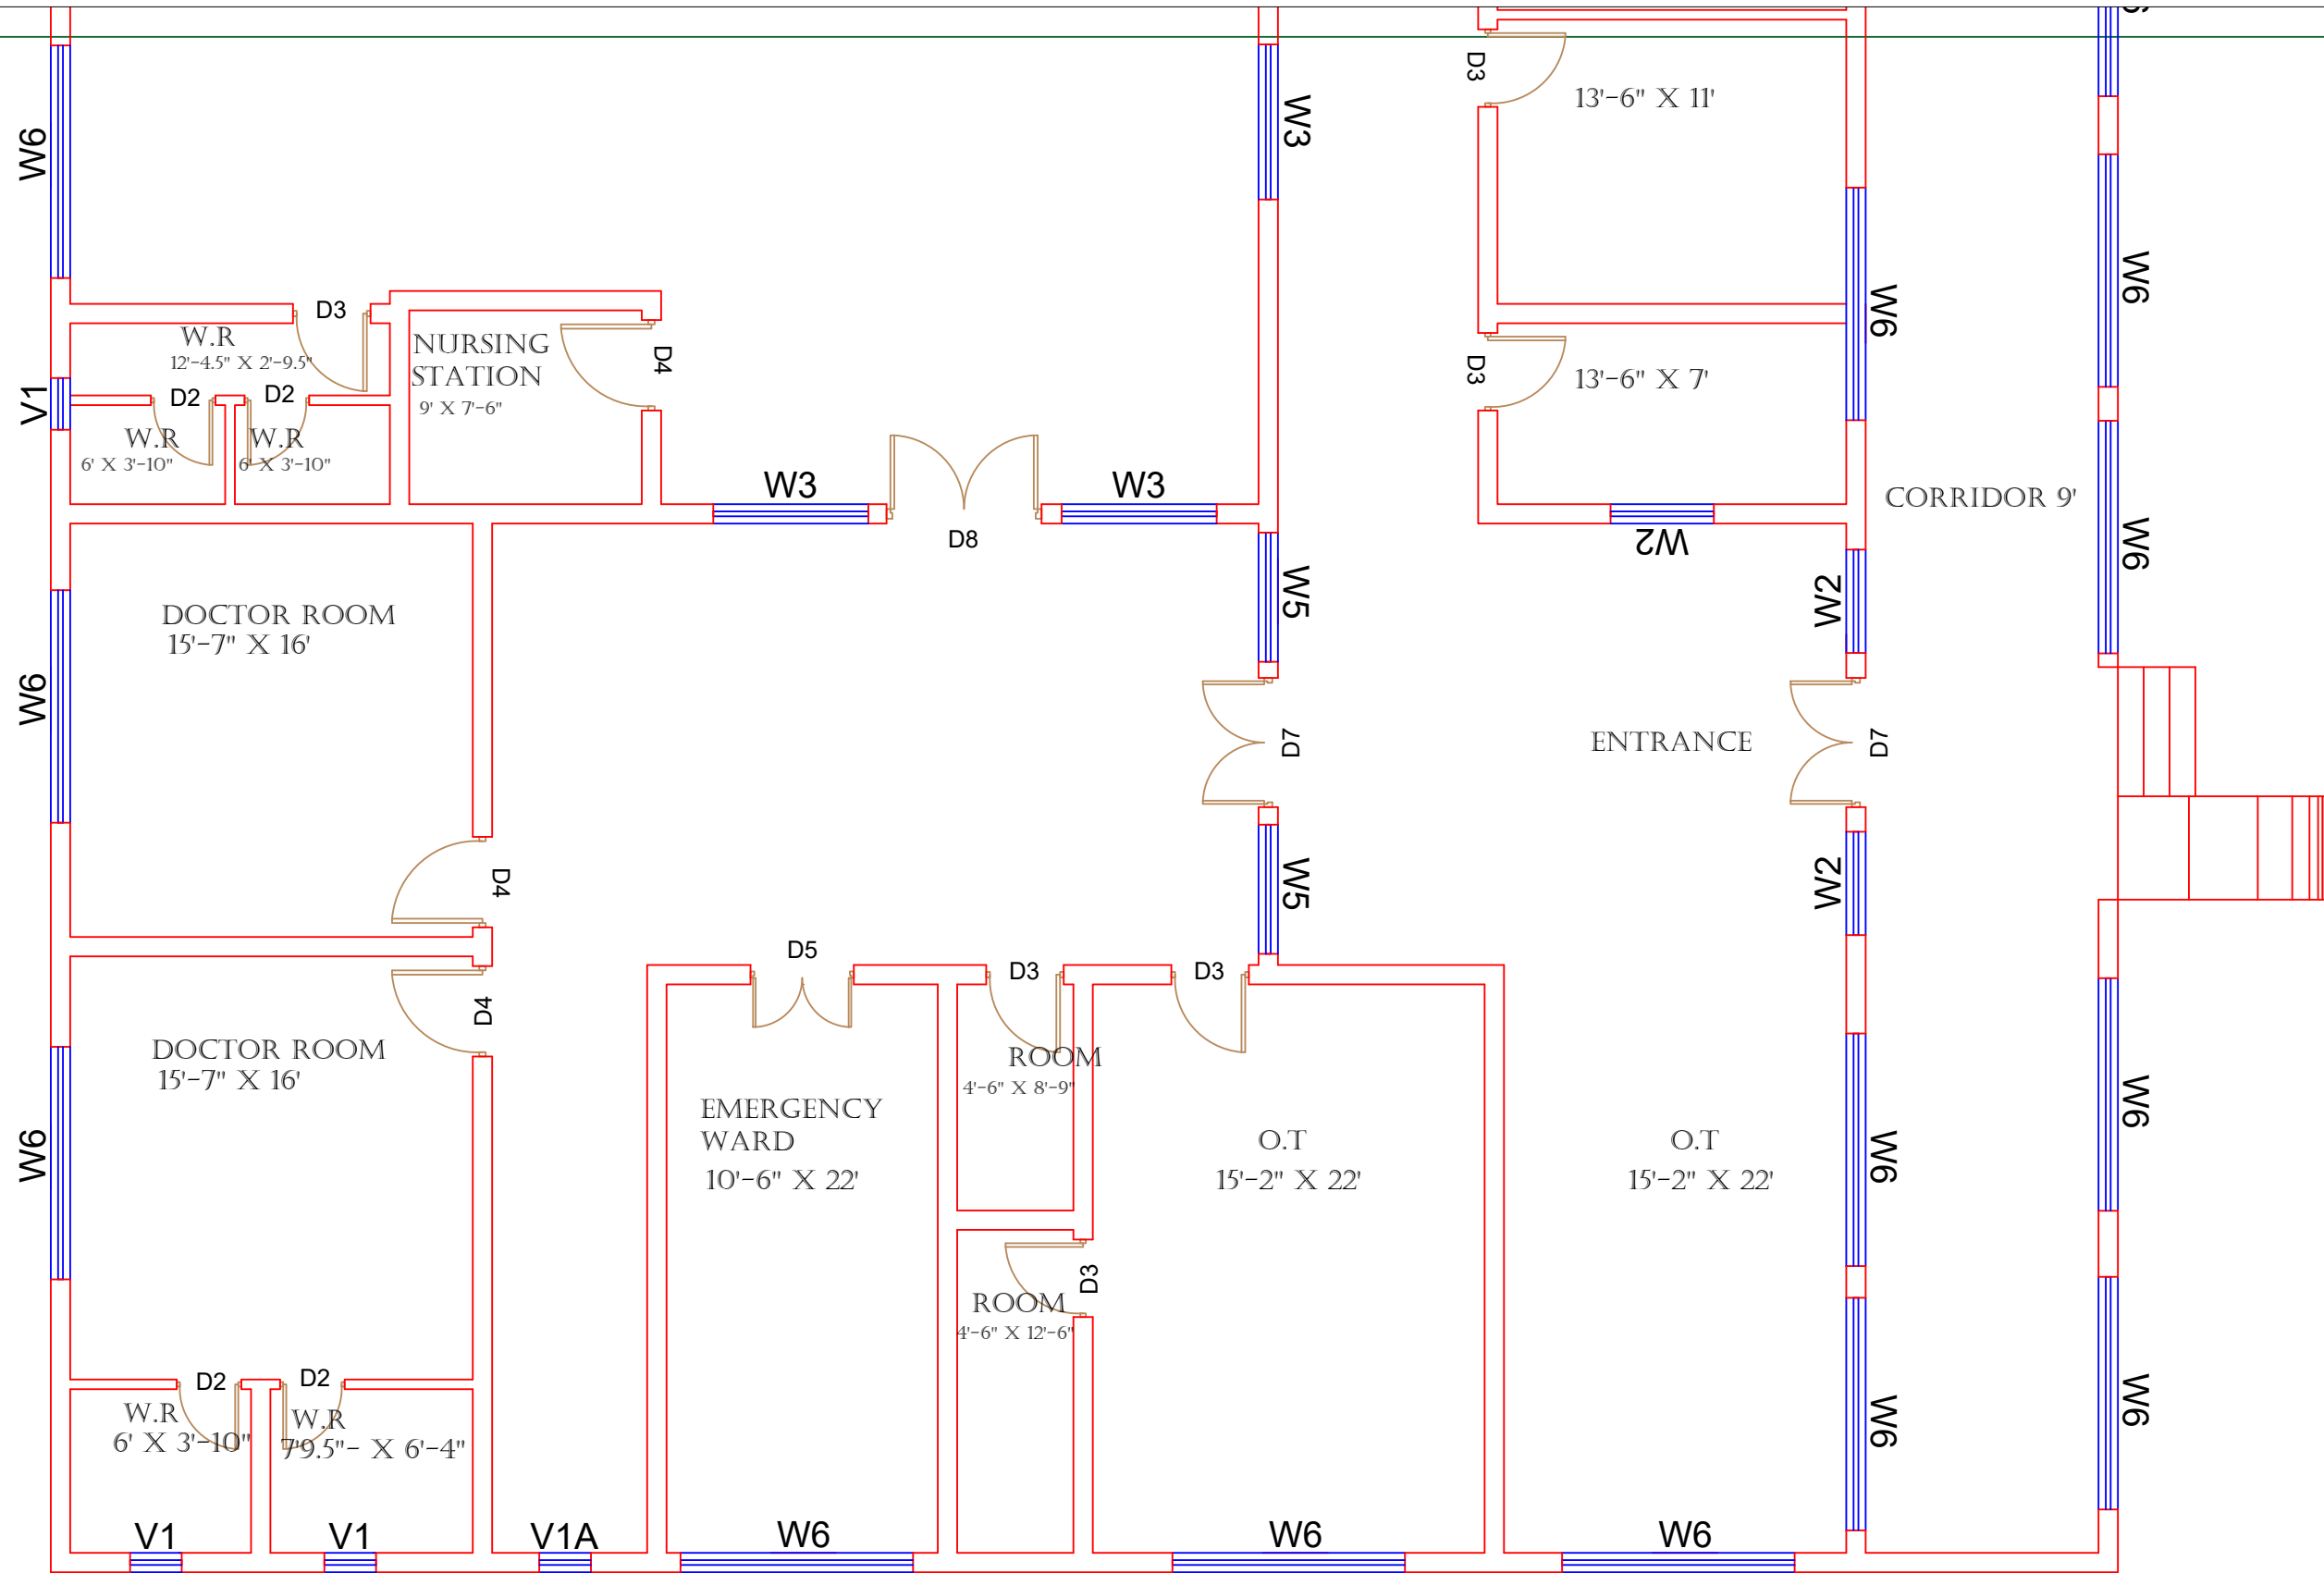

### Legends:

Residential Area	
Road	
Wall	
Power Line	
OHT	
Tree	
Man Hole	
Tube Well	
Light Pole	
Lawns	
Earthen Areas	
Asphalts Roads	
Tough Pavers	
P.C.C / Plinth Protection	
Boundary Wall	
Brick Pavers / Soling	
Drain	
Tap	
Hand Pump	
Air Conditioner	
Tube Light	
Fan	
Roof Light	
Bulb	

AREA	
AREA WITHIN BOUNDARY WALL	75074.850 Sft
AREA OF CLINICAL BLOCK	61286.133 Sft
PLINTH AREA OF BLOCK	20428.711 Sft

OPENING SCHEDULE OF DOORS AND WINDOWS					
DOORS	WIDTH	HEIGHT	WINDOWS	WIDTH	HEIGHT
D1	2'-0"	7'-0"	W1	3'-0"	5'-0"
D2	2'-6"	7'-0"	W2	4'-0"	4'-0"
D3	3'-0"	7'-0"	W3	6'-0"	6'-0"
D4	3'-6"	7'-0"	W4	8'-0"	8'-0"
D5	4'-0"	7'-0"	W5	5'-0"	5'-0"
D6	4'-6"	7'-0"	W6	9'-0"	8'-6"
D7	5'-0"	7'-0"	W7	11'-0"	8'-6"
D8	6'-0"	7'-0"	V1	2'-0"	2'-0"
D9	7'-0"	7'-0"	V1A	2'-0"	2'-0"

Project:  
**CAD MAPPING OF TEHSIL HEAD QUARTER HOSPITALS, PUNJAB**


Client:	Consultant:
 GOVERNMENT OF THE PUNJAB PRIMARY & SECONDARY HEALTHCARE DEPARTMENT	 SKAFS CONSULTANT (Pvt.) Limited ENGINEERING AND ENVIRONMENT CONSULTANT

Drawing Title:  
**THQ TALAGANG CITY  
CLINICAL BLOCK PLAN (PART 3)**

Drawing No.  
**SKAFS/TALAGANG-C/11**

# CLINICAL BLOCK OF THQ HOSPITAL TALAGANG CITY

## FIRST FLOOR

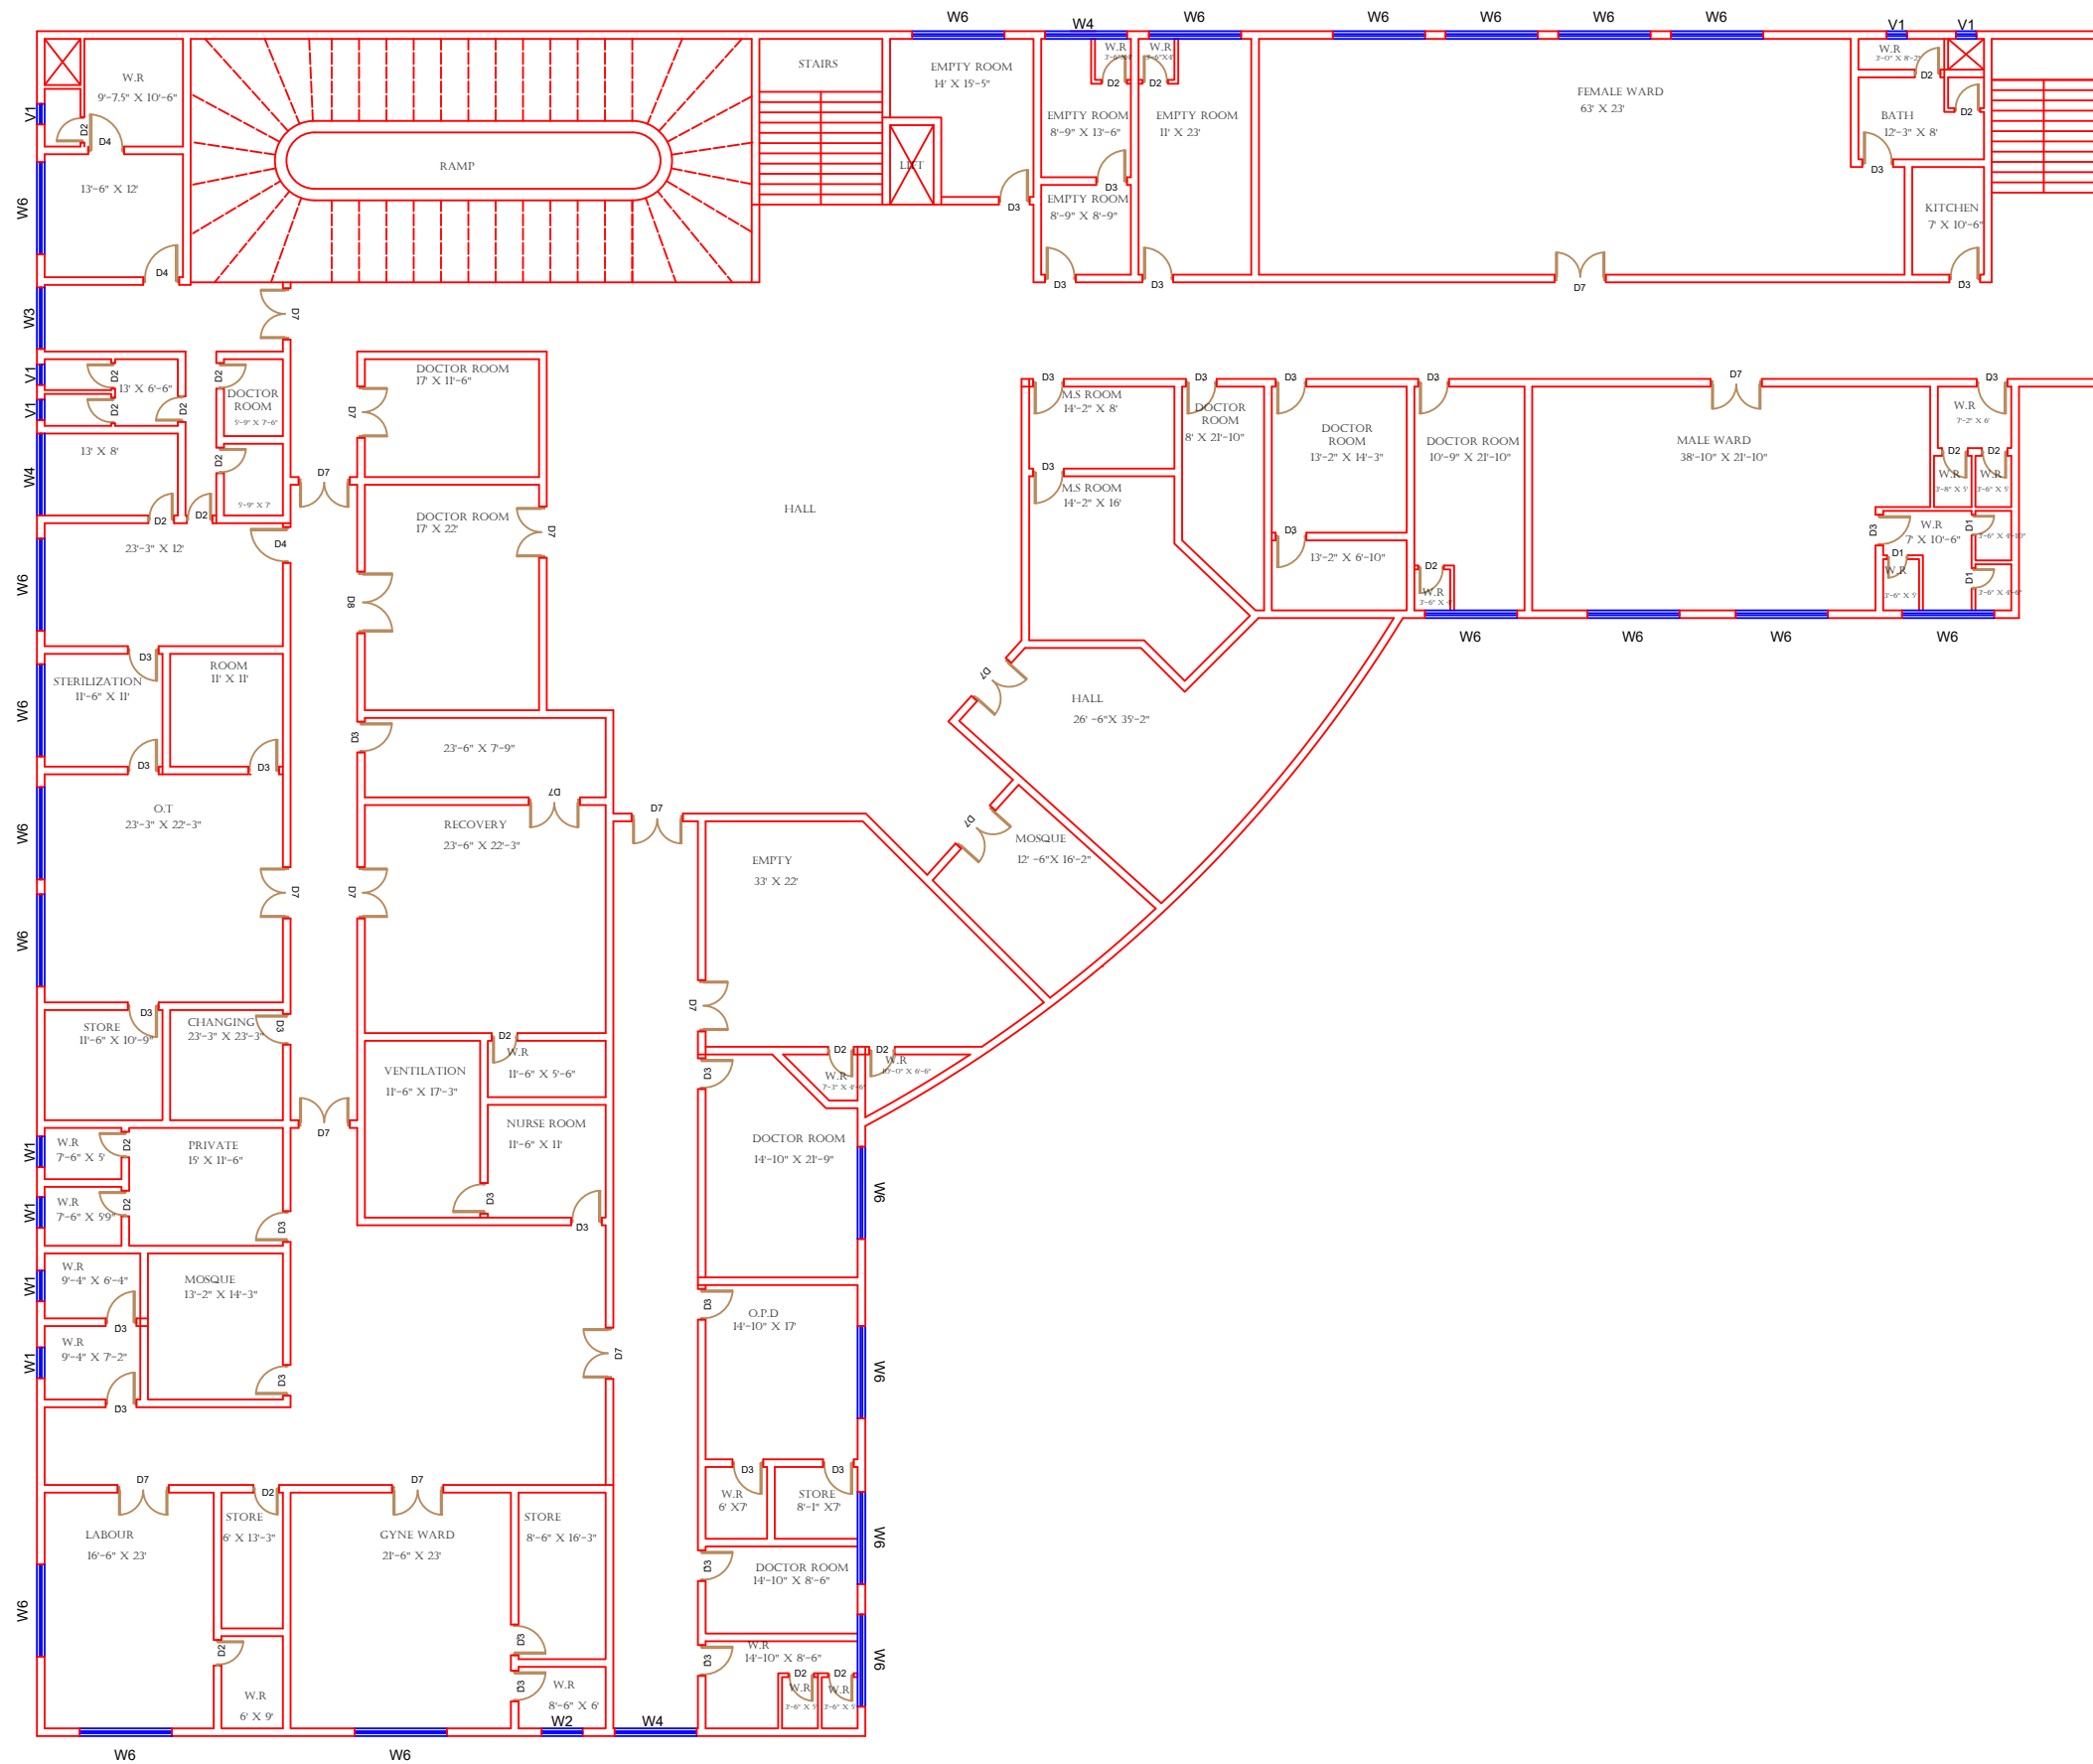

### Legends:

Residential Area	
Road	
Wall	
Power Line	
OHT	
Tree	
Man Hole	
Tube Well	
Light Pole	
Lawns	
Earthen Areas	
Asphalts Roads	
Tough Pavers	
P.C.C / Plinth Protection	
Boundary Wall	
Brick Pavers / Soling	
Drain	
Tap	
Hand Pump	
Air Conditioner	
Tube Light	
Fan	
Roof Light	
Bulb	

AREA	
AREA WITHIN BOUNDARY WALL	75074.850 Sft
AREA OF CLINICAL BLOCK	61286.133 Sft
PLINTH AREA OF BLOCK	20428.711 Sft

OPENING SCHEDULE OF DOORS AND WINDOWS					
DOORS	WIDTH	HEIGHT	WINDOWS	WIDTH	HEIGHT
D1	2'-0"	7'-0"	W1	3'-0"	5'-0"
D2	2'-6"	7'-0"	W2	4'-0"	4'-0"
D3	3'-0"	7'-0"	W3	6'-0"	6'-0"
D4	3'-6"	7'-0"	W4	8'-0"	8'-0"
D5	4'-0"	7'-0"	W5	5'-0"	5'-0"
D6	4'-6"	7'-0"	W6	9'-0"	8'-6"
D7	5'-0"	7'-0"	W7	11'-0"	8'-6"
D8	6'-0"	7'-0"	V1	2'-0"	2'-0"
D9	7'-0"	7'-0"	V1A	2'-0"	2'-0"

Project:  
**CAD MAPPING OF TEHSIL HEAD QUARTER HOSPITALS, PUNJAB**

Client: GOVERNMENT OF THE PUNJAB  
PRIMARY & SECONDARY HEALTHCARE DEPARTMENT


Consultant: SKAFS CONSULTANT (Pvt.) Limited  
ENGINEERING AND ENVIRONMENT CONSULTANT

Drawing Title:  
**THQ TALAGANG CITY FIRST FLOOR PLAN**

Drawing No. **SKAFS/TALAGANG-C/12**

# CLINICAL BLOCK OF THQ HOSPITAL TALAGANG CITY

## SECOND FLOOR

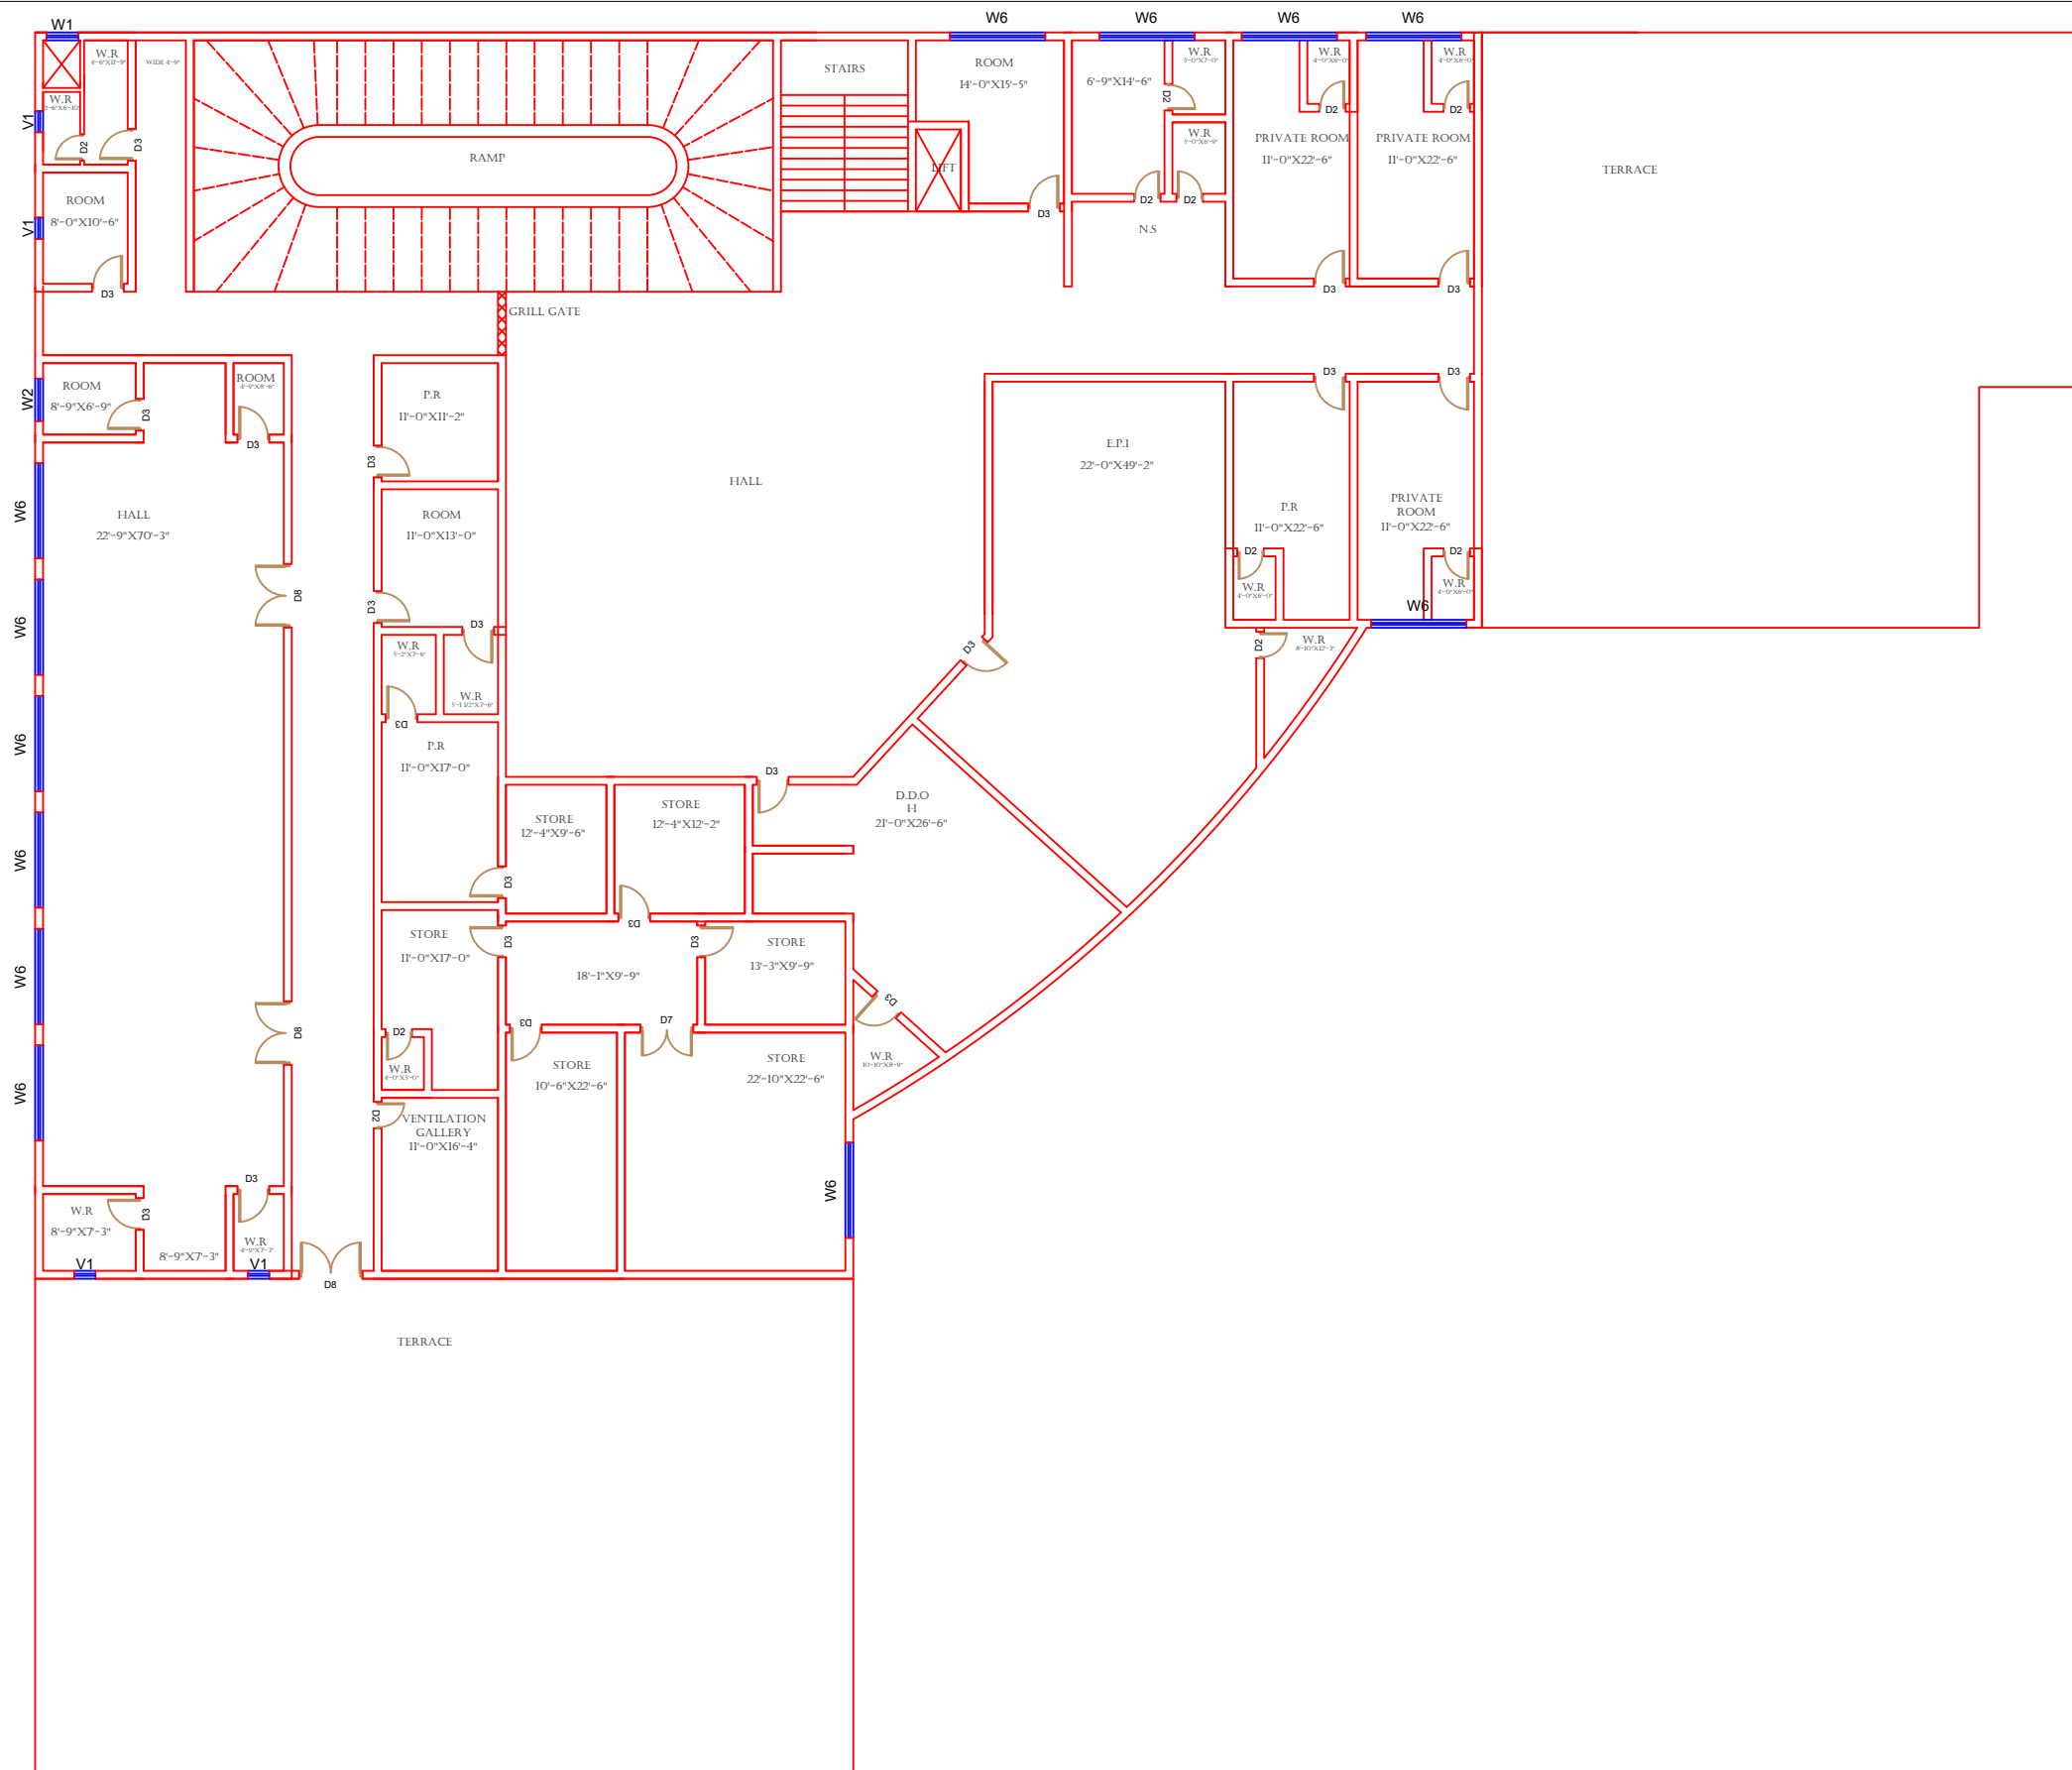

### Legends:

Residential Area	
Road	
Wall	
Power Line	
OHT	
Tree	
Man Hole	
Tube Well	
Light Pole	
Lawns	
Earthen Areas	
Asphalts Roads	
Tough Pavers	
P.C.C / Plinth Protection	
Boundary Wall	
Brick Pavers / Soling	
Drain	
Tap	
Hand Pump	
Air Conditioner	
Tube Light	
Fan	
Roof Light	
Bulb	

### AREA

AREA WITHIN BOUNDARY WALL	75074.850 Sft
AREA OF CLINICAL BLOCK	61286.133 Sft
PLINTH AREA OF BLOCK	20428.711 Sft

### OPENING SCHEDULE OF DOORS AND WINDOWS

DOORS	WIDTH	HEIGHT	WINDOWS	WIDTH	HEIGHT
D1	2'-0"	7'-0"	W1	3'-0"	5'-0"
D2	2'-6"	7'-0"	W2	4'-0"	4'-0"
D3	3'-0"	7'-0"	W3	6'-0"	6'-0"
D4	3'-6"	7'-0"	W4	8'-0"	8'-0"
D5	4'-0"	7'-0"	W5	5'-0"	5'-0"
D6	4'-6"	7'-0"	W6	9'-0"	8'-6"
D7	5'-0"	7'-0"	W7	11'-0"	8'-6"
D8	6'-0"	7'-0"	V1	2'-0"	2'-0"
D9	7'-0"	7'-0"	V1A	2'-0"	2'-0"

Project:  
**CAD MAPPING OF TEHSIL HEAD QUARTER HOSPITALS, PUNJAB**


Client: GOVERNMENT OF THE PUNJAB  
PRIMARY & SECONDARY HEALTHCARE DEPARTMENT

Consultant: SKAFS CONSULTANT (Pvt.) Limited  
ENGINEERING AND ENVIRONMENT CONSULTANT

Drawing Title:  
**THQ TALAGANG CITY SECOND FLOOR PLAN**

Drawing No. **SKAFS/TALAGANG-C13**

# ELECTRICAL LAYOUT PLAN OF THQ HOSPITAL TALAGANG CITY GROUND FLOOR

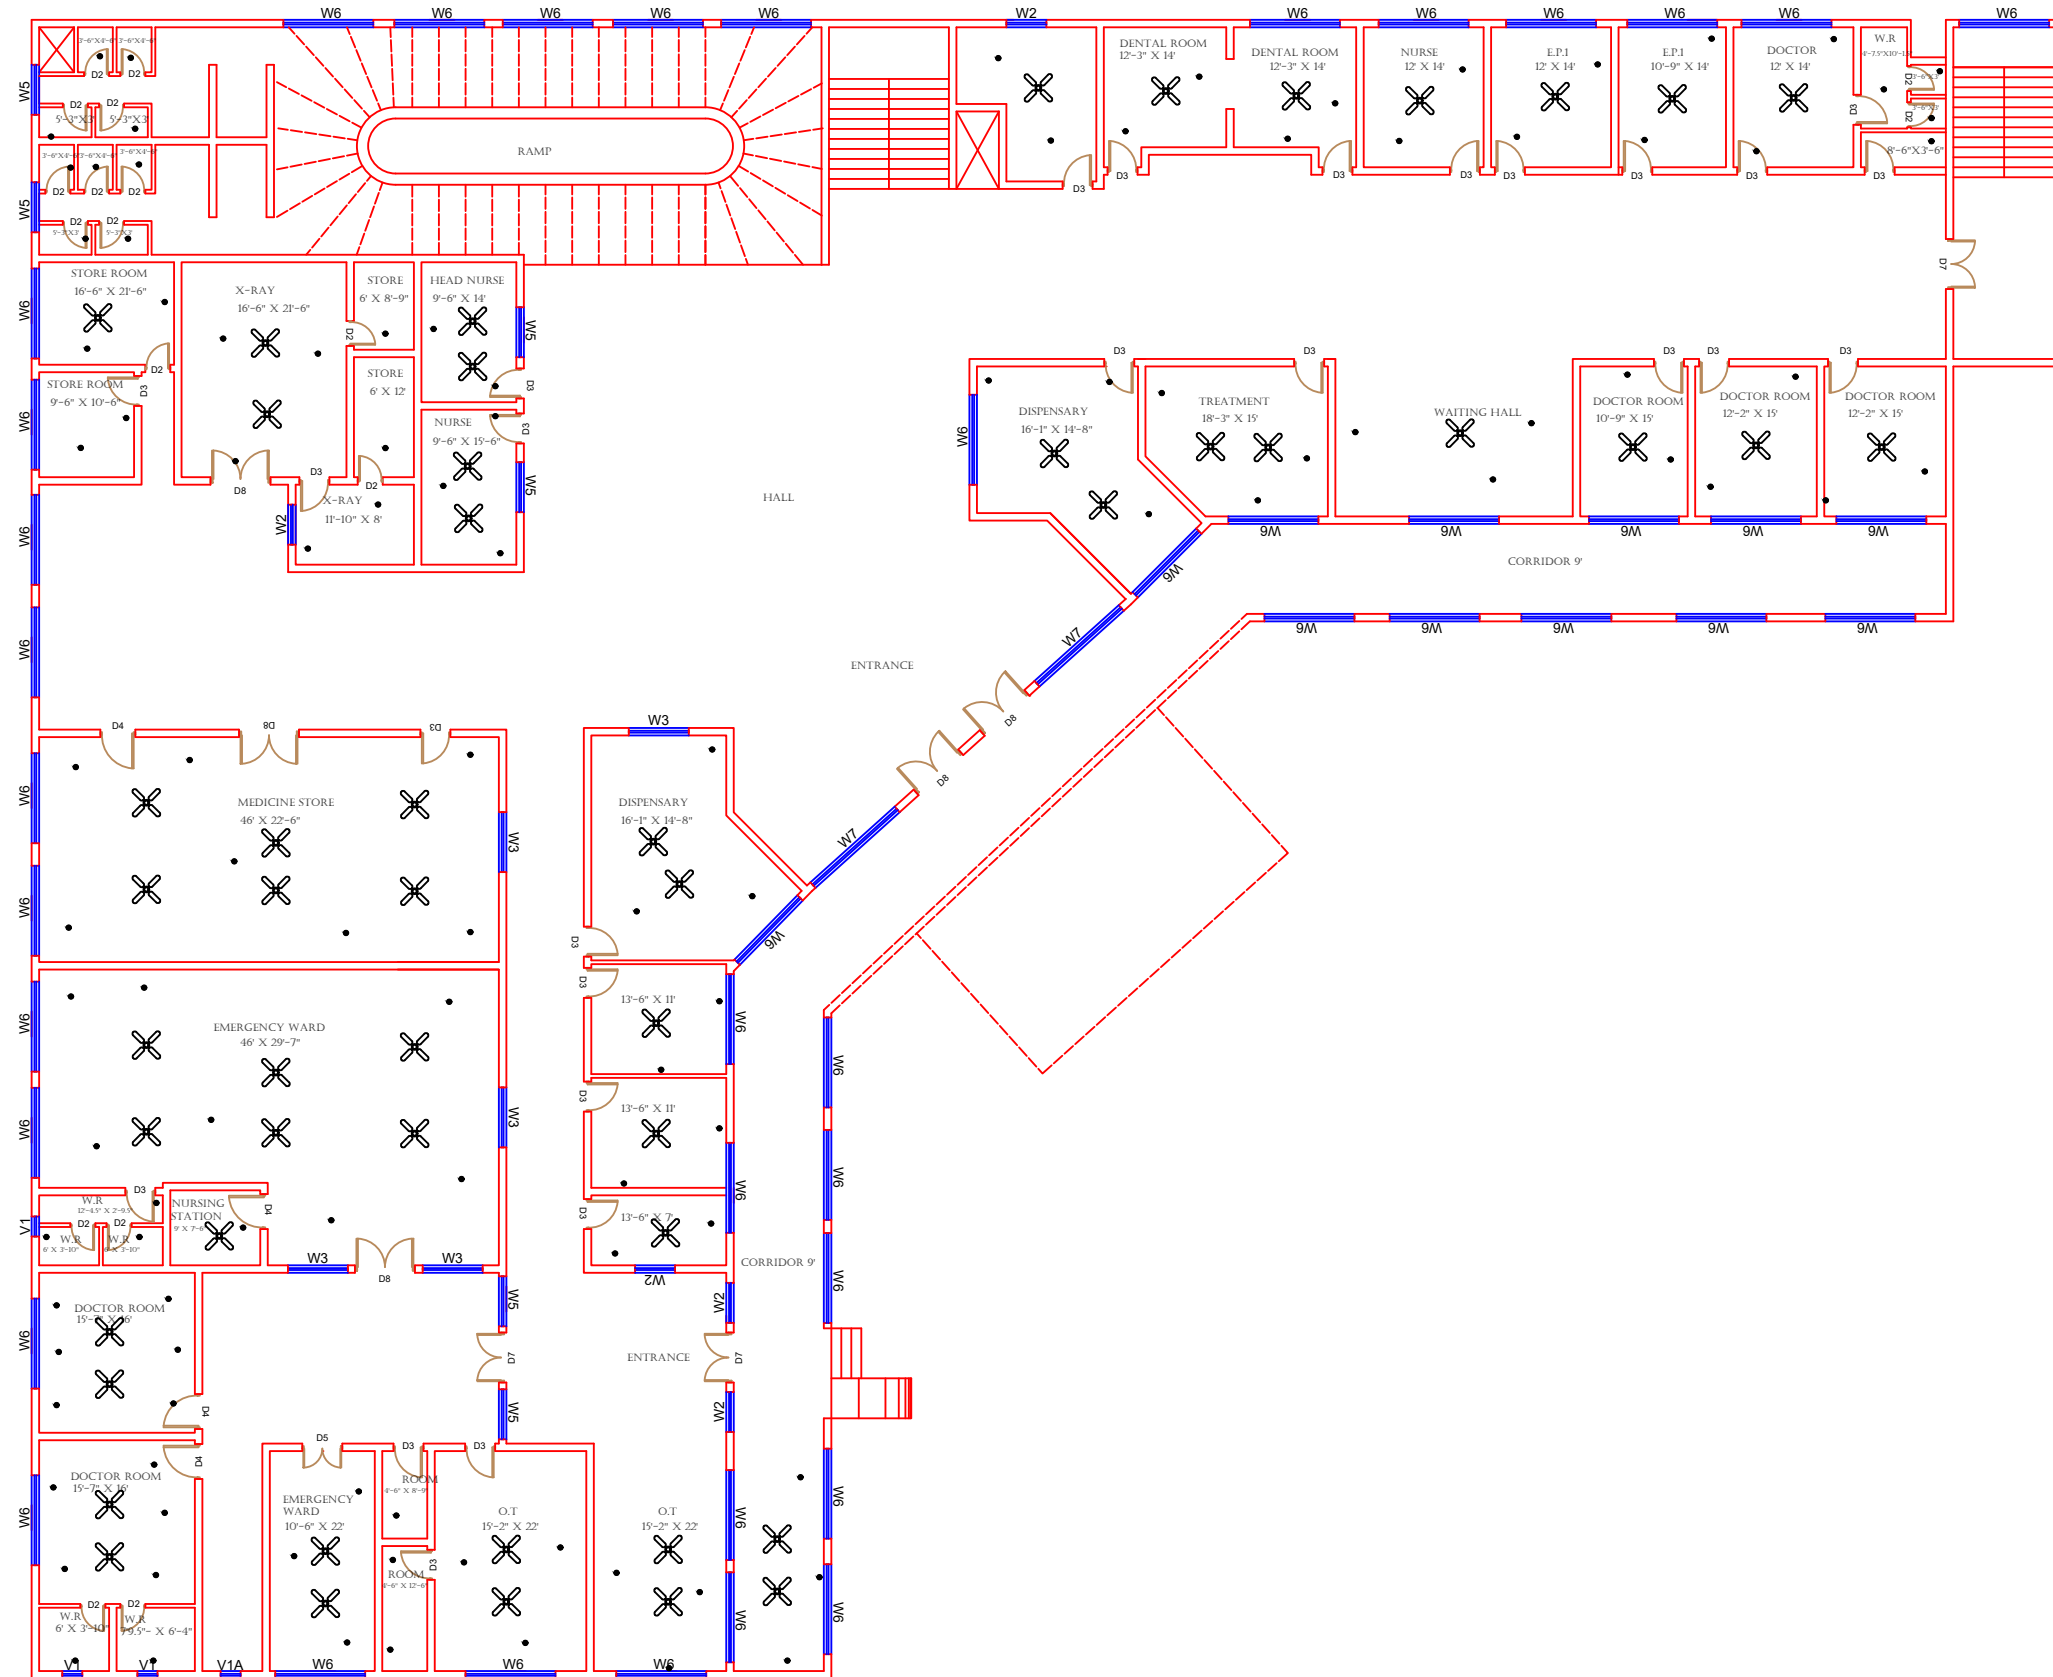

## Legends:

Residential Area	
Road	
Wall	
Power Line	
OHT	
Tree	
Man Hole	
Tube Well	
Light Pole	
Lawns	
Earthen Areas	
Asphalts Roads	
Tough Pavers	
P.C.C / Plinth Protection	
Boundary Wall	
Brick Pavers / Soling	
Drain	
Tap	
Hand Pump	
Air Conditioner	
Tube Light	
Fan	
Roof Light	
Bulb	

AREA	
AREA WITHIN BOUNDARY WALL	75074.850 Sft
AREA OF CLINICAL BLOCK	61286.133 Sft
PLINTH AREA OF BLOCK	20428.711 Sft

OPENING SCHEDULE OF DOORS AND WINDOWS					
DOORS	WIDTH	HEIGHT	WINDOWS	WIDTH	HEIGHT
D1	2'-0"	7'-0"	W1	3'-0"	5'-0"
D2	2'-6"	7'-0"	W2	4'-0"	4'-0"
D3	3'-0"	7'-0"	W3	6'-0"	6'-0"
D4	3'-6"	7'-0"	W4	8'-0"	8'-0"
D5	4'-0"	7'-0"	W5	5'-0"	5'-0"
D6	4'-6"	7'-0"	W6	9'-0"	8'-6"
D7	5'-0"	7'-0"	W7	11'-0"	8'-6"
D8	6'-0"	7'-0"	V1	2'-0"	2'-0"
D9	7'-0"	7'-0"	V1A	2'-0"	2'-0"

Project:  
**CAD MAPPING OF TEHSIL  
HEAD QUARTER HOSPITALS,  
PUNJAB**


Client: GOVERNMENT OF THE PUNJAB  
PRIMARY & SECONDARY  
HEALTHCARE DEPARTMENT

Consultant: SKAFS CONSULTANT (Pvt.)  
Limited  
ENGINEERING AND ENVIRONMENT  
CONSULTANT

Drawing Title:  
**THQ TALAGANG CITY  
ELECTRICAL PLAN (GROUND FLOOR)**

Drawing No. **SKAFS/TALAGANG-C14**

# ELECTRICAL LAYOUT PLAN OF THQ HOSPITAL TALAGANG CITY FIRST FLOOR

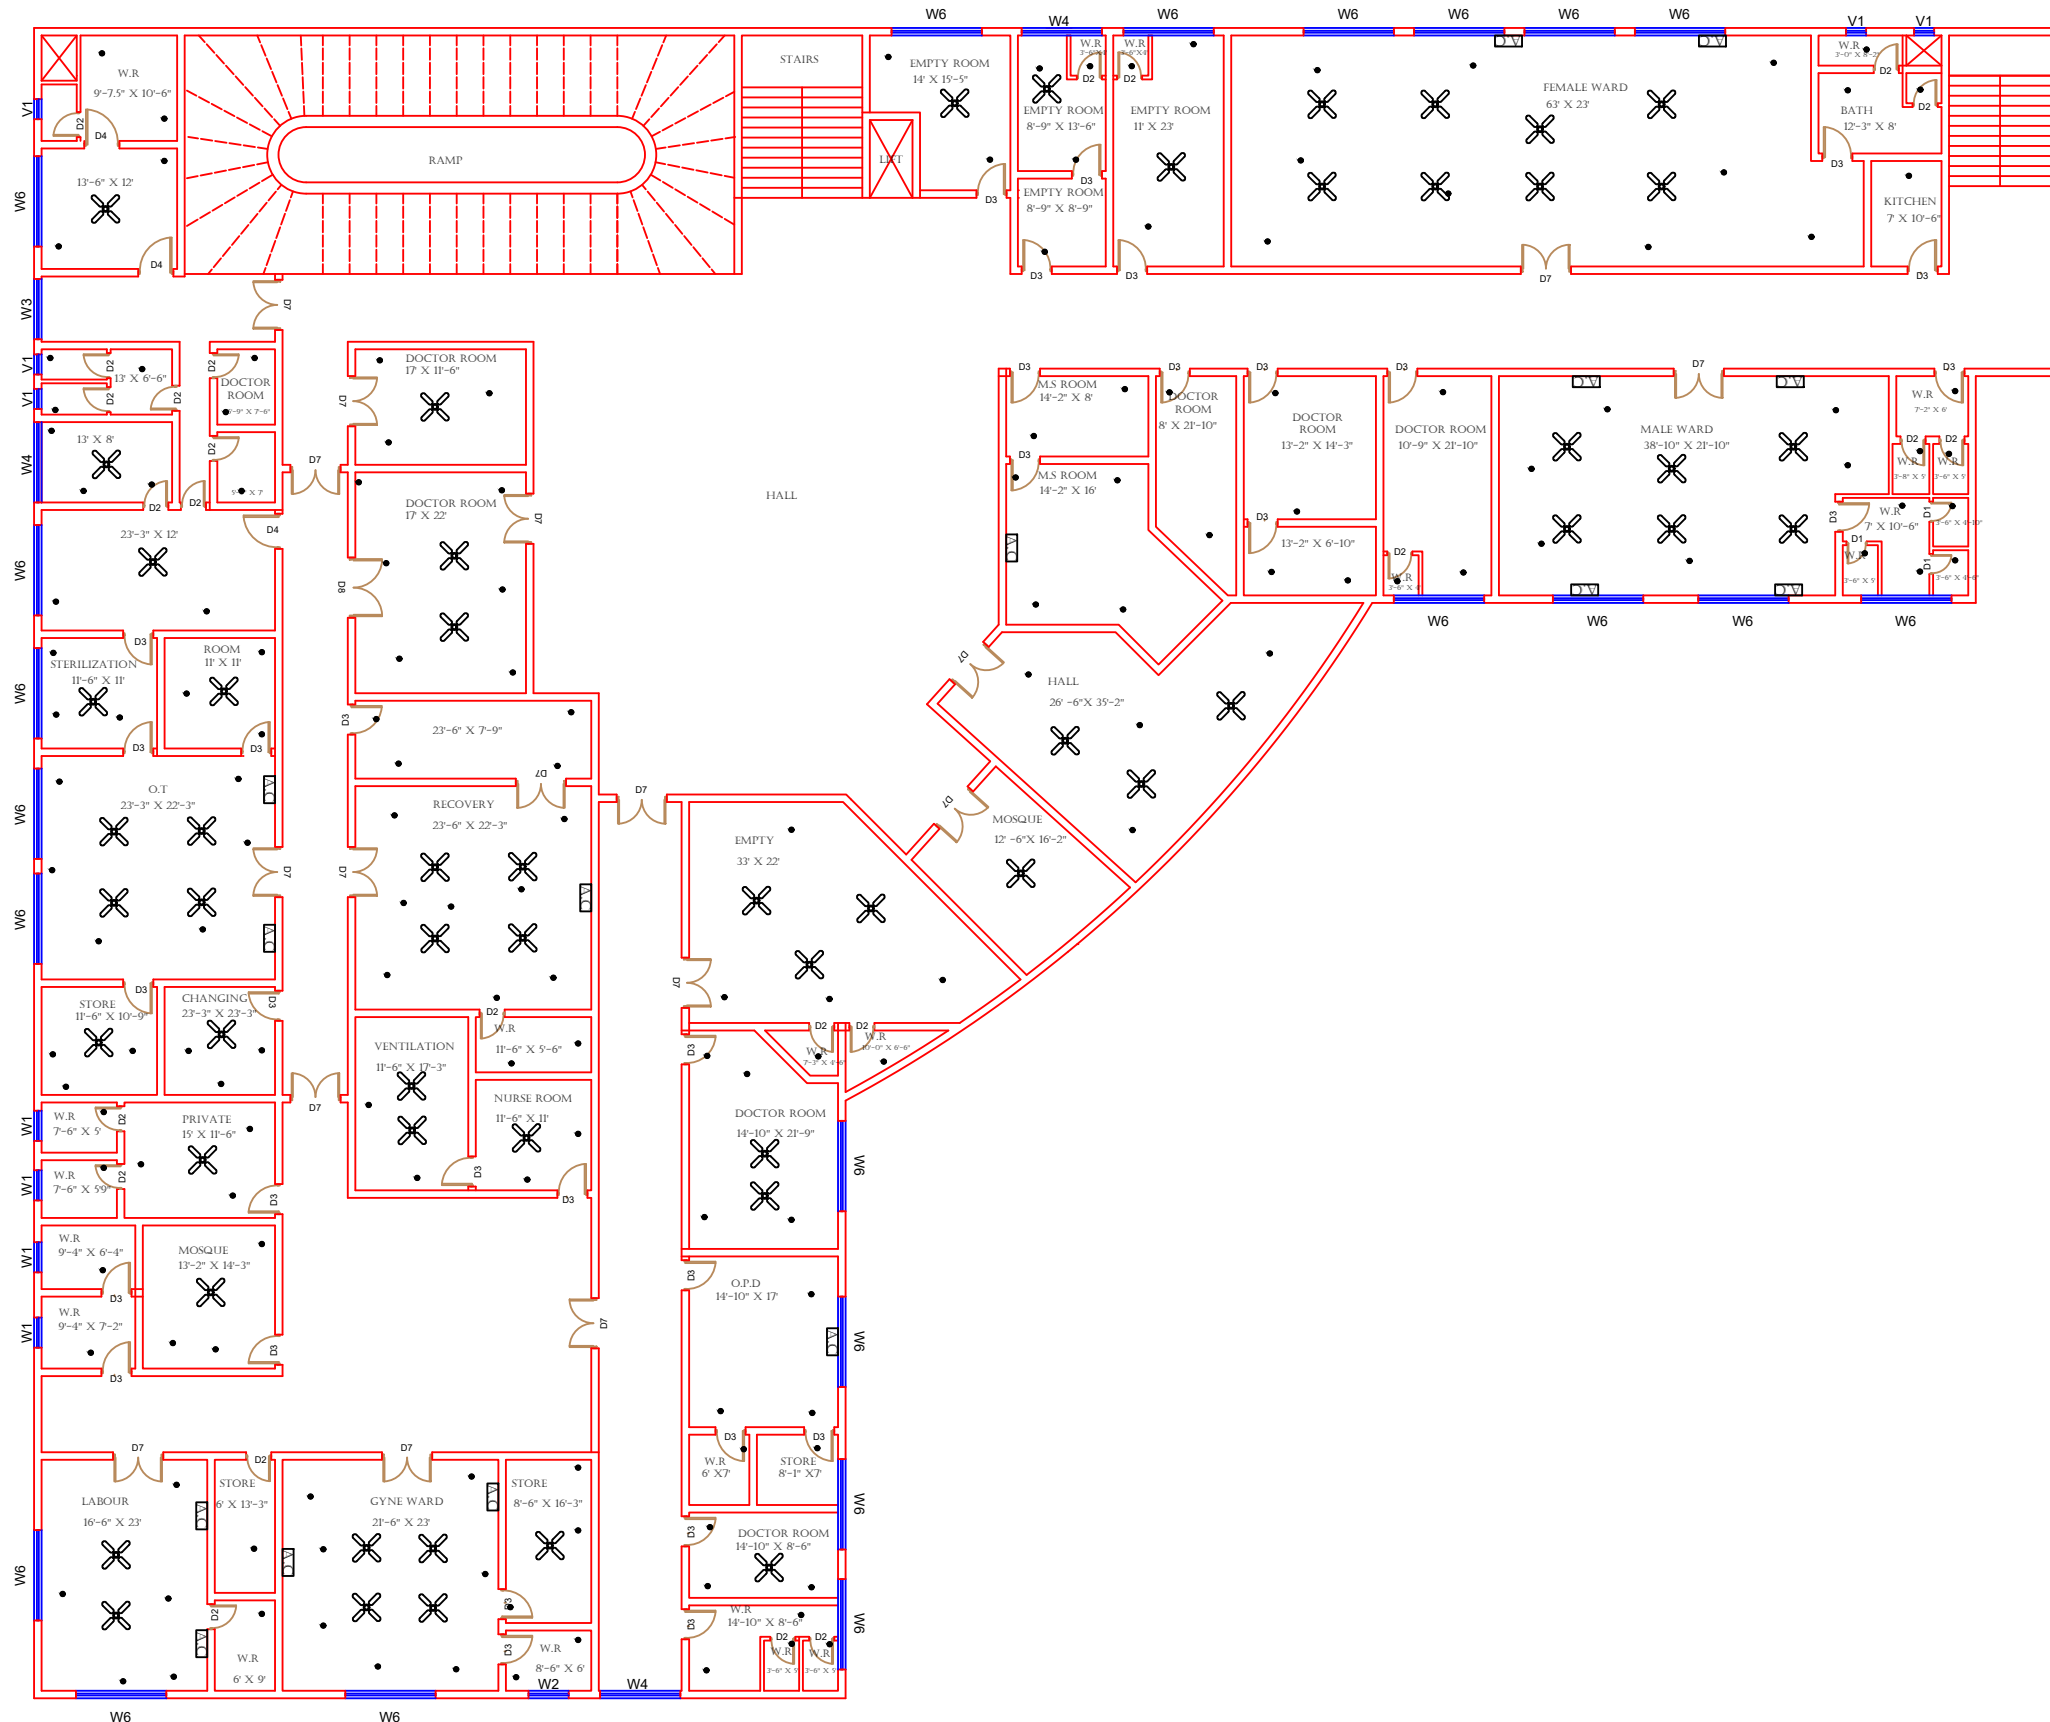

### Legends:

Residential Area	
Road	
Wall	
Power Line	
OHT	
Tree	
Man Hole	
Tube Well	
Light Pole	
Lawns	
Earthen Areas	
Asphalts Roads	
Tough Pavers	
P.C.C / Plinth Protection	
Boundary Wall	
Brick Pavers / Soling	
Drain	
Tap	
Hand Pump	
Air Conditioner	
Tube Light	
Fan	
Roof Light	
Bulb	

AREA	
AREA WITHIN BOUNDARY WALL	75074.850 Sft
AREA OF CLINICAL BLOCK	61286.133 Sft
PLINTH AREA OF BLOCK	20428.711 Sft

OPENING SCHEDULE OF DOORS AND WINDOWS					
DOORS	WIDTH	HEIGHT	WINDOWS	WIDTH	HEIGHT
D1	2'-0"	7'-0"	W1	3'-0"	5'-0"
D2	2'-6"	7'-0"	W2	4'-0"	4'-0"
D3	3'-0"	7'-0"	W3	6'-0"	6'-0"
D4	3'-6"	7'-0"	W4	8'-0"	8'-0"
D5	4'-0"	7'-0"	W5	5'-0"	5'-0"
D6	4'-6"	7'-0"	W6	9'-0"	8'-6"
D7	5'-0"	7'-0"	W7	11'-0"	8'-6"
D8	6'-0"	7'-0"	V1	2'-0"	2'-0"
D9	7'-0"	7'-0"	V1A	2'-0"	2'-0"

Project:  
**CAD MAPPING OF TEHSIL  
HEAD QUARTER HOSPITALS,  
PUNJAB**


Client:  GOVERNMENT OF THE PUNJAB PRIMARY & SECONDARY HEALTHCARE DEPARTMENT	Consultant:  SKAFS CONSULTANT (Pvt.) Limited ENGINEERING AND ENVIRONMENT CONSULTANT
---	--

Drawing Title:  
**THQ TALAGANG CITY  
ELECTRICAL PLAN (FIRST FLOOR)**

Drawing No.  
**SKAFS/TALAGANG-C15**



# ELECTRICAL LAYOUT PLAN OF THQ HOSPITAL TALAGANG CITY SECOND FLOOR

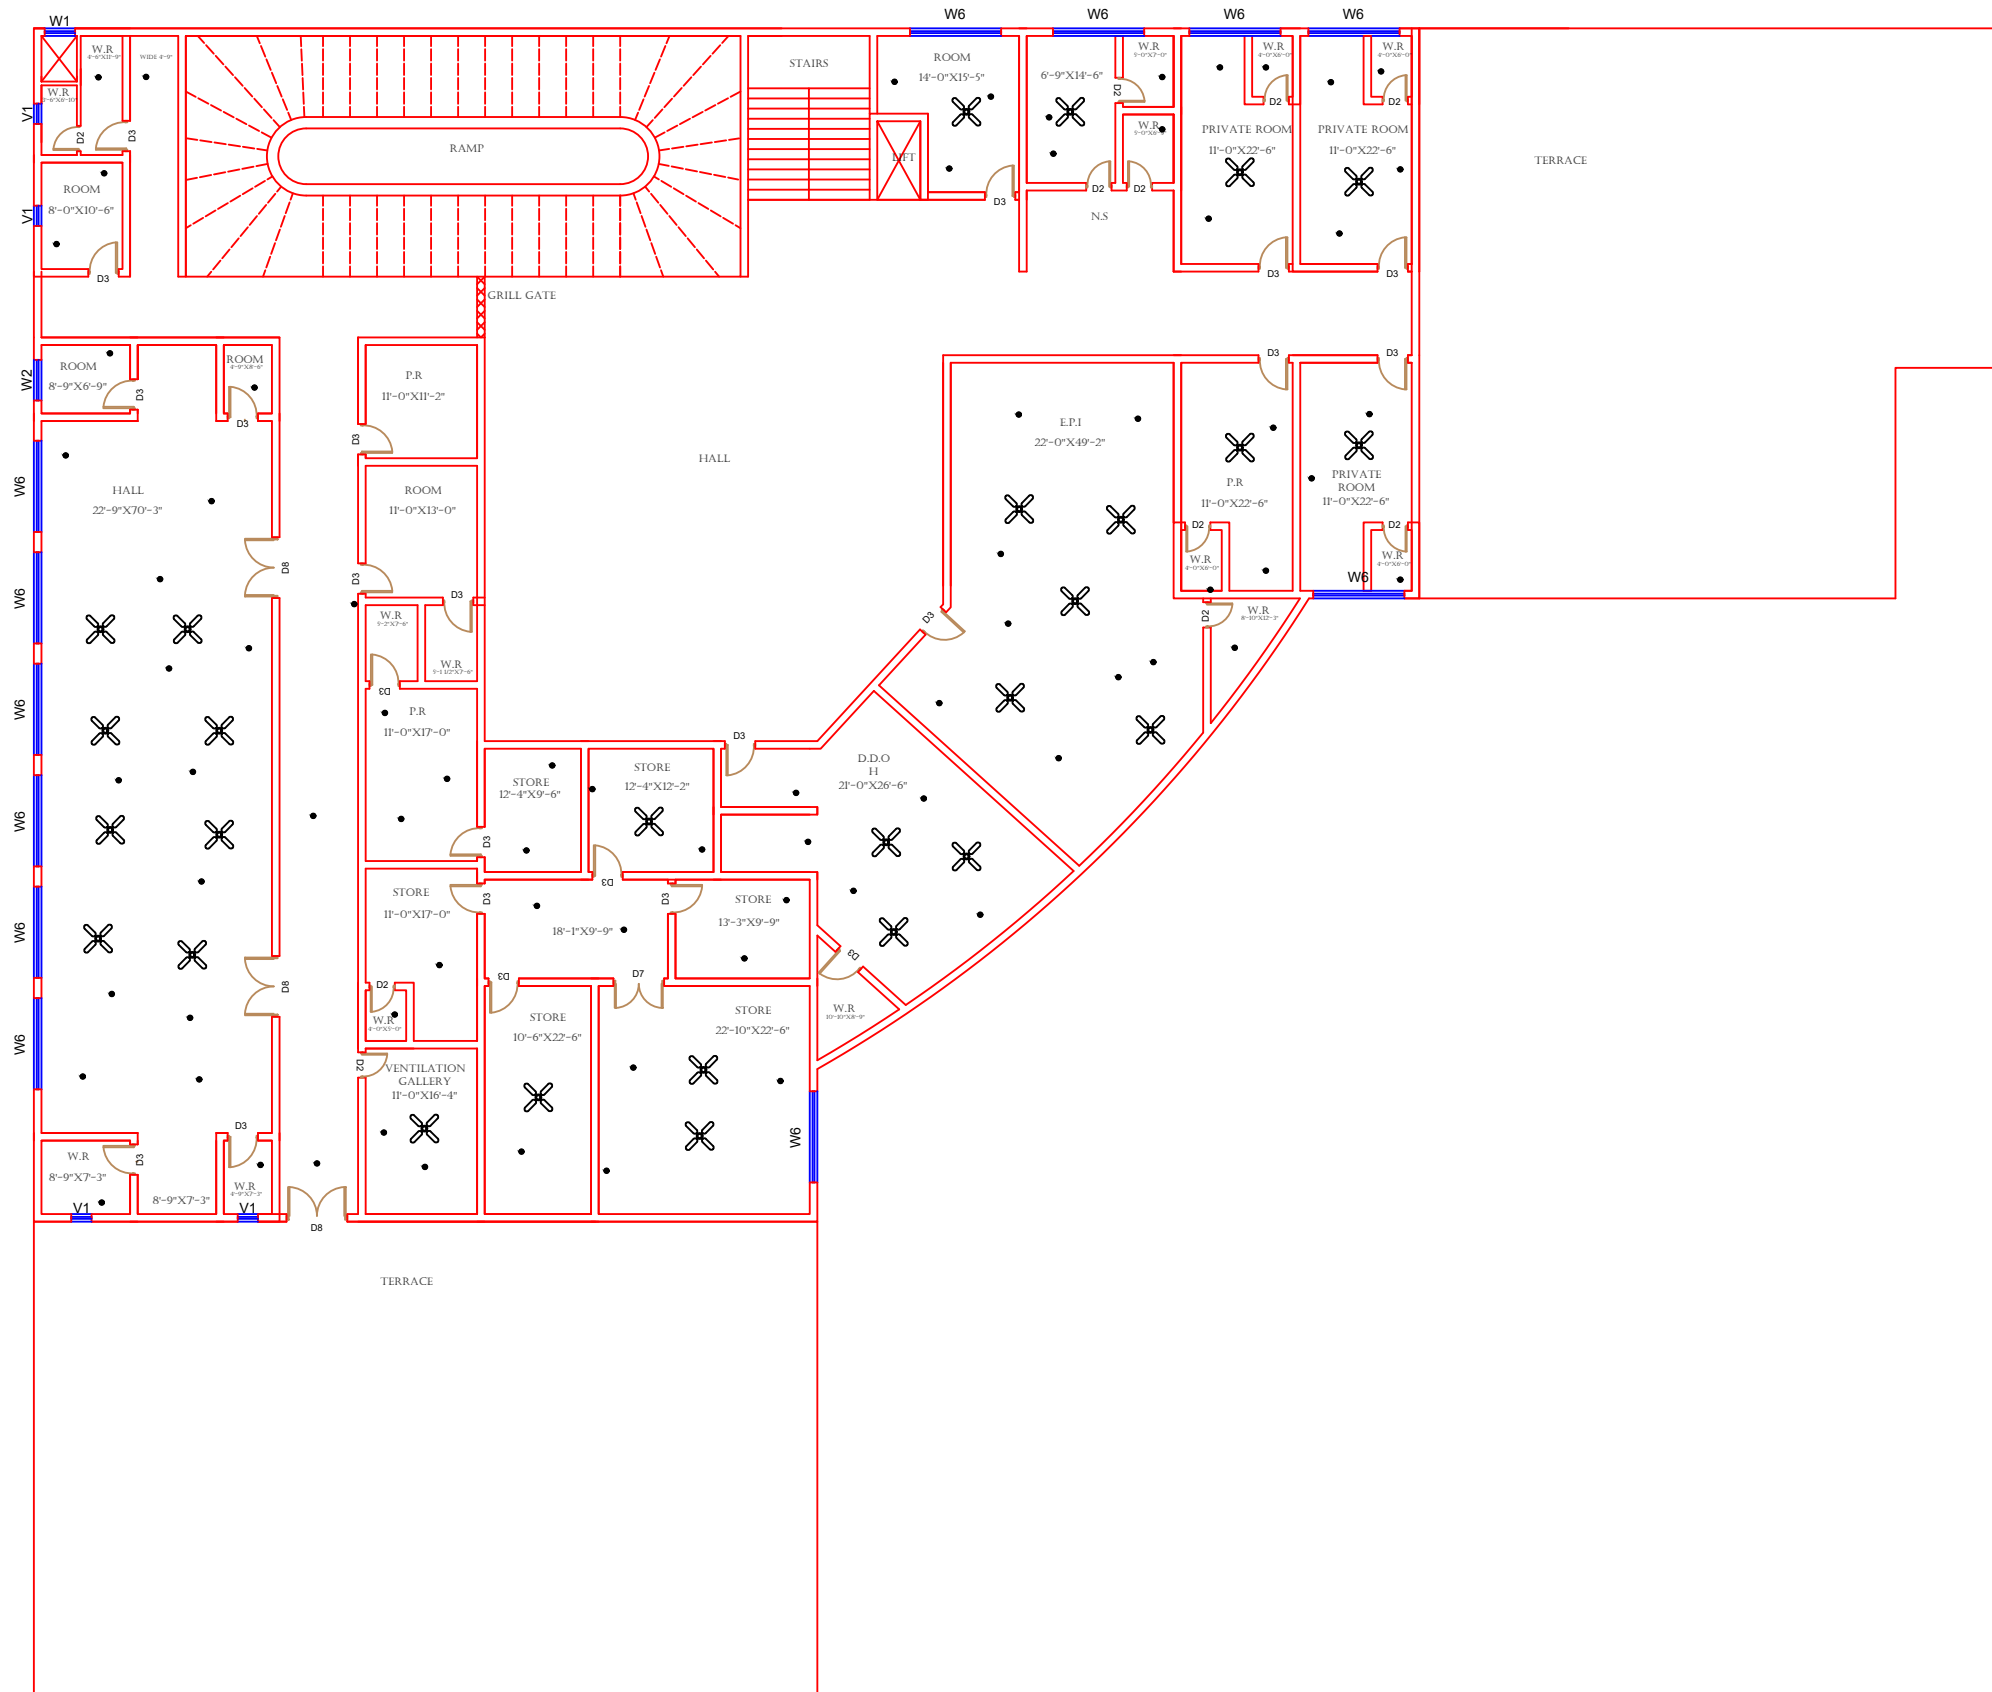

### Legends:

Residential Area	
Road	
Wall	
Power Line	
OHT	
Tree	
Man Hole	
Tube Well	
Light Pole	
Lawns	
Earthen Areas	
Asphalts Roads	
Tough Pavers	
P.C.C / Plinth Protection	
Boundary Wall	
Brick Pavers / Soling	
Drain	
Tap	
Hand Pump	
Air Conditioner	
Tube Light	
Fan	
Roof Light	
Bulb	

AREA	
AREA WITHIN BOUNDARY WALL	75074.850 Sft
AREA OF CLINICAL BLOCK	61286.133 Sft
PLINTH AREA OF BLOCK	20428.711 Sft

OPENING SCHEDULE OF DOORS AND WINDOWS					
DOORS	WIDTH	HEIGHT	WINDOWS	WIDTH	HEIGHT
D1	2'-0"	7'-0"	W1	3'-0"	5'-0"
D2	2'-6"	7'-0"	W2	4'-0"	4'-0"
D3	3'-0"	7'-0"	W3	6'-0"	6'-0"
D4	3'-6"	7'-0"	W4	8'-0"	8'-0"
D5	4'-0"	7'-0"	W5	5'-0"	5'-0"
D6	4'-6"	7'-0"	W6	9'-0"	8'-6"
D7	5'-0"	7'-0"	W7	11'-0"	8'-6"
D8	6'-0"	7'-0"	V1	2'-0"	2'-0"
D9	7'-0"	7'-0"	V1A	2'-0"	2'-0"

Project:  
**CAD MAPPING OF TEHSIL  
HEAD QUARTER HOSPITALS,  
PUNJAB**

Client:  GOVERNMENT OF THE PUNJAB PRIMARY & SECONDARY HEALTHCARE DEPARTMENT	Consultant:  SKAFS CONSULTANT (Pvt.) Limited ENGINEERING AND ENVIRONMENT CONSULTANT
---	--

Drawing Title:  
**THQ TALAGANG CITY  
ELECTRICAL PLAN (SECOND FLOOR)**

Drawing No.  
**SKAFS/TALAGANG-C16**