

# MASTER PLAN OF THQ HOSPITAL TANDIYAWALA

PART 1

PART 2

PART 3

PART 4



Legends:

RESIDENTIAL AREA	
ROAD	
WALL	
POWER LINE	
OHT	
TREE	
MANHOLE	
TUBE WELL	
LIGHT POLE	
LAWNS	
EARTHEN AREAS	
ASPHALTS ROADS	
TOUGH PAVERS	
P.C.C /PLINTH PROTECTION	
BOUNDARY WALL	
TAP	
HAND PUMP	
BRICK PAVERS	
AIR CONDITIONER	
TUBE LIGHT	
FAN	
ROOF LIGHT	
BULB	

AREA	
AREA WITHIN BOUNDARY WALL	287604.20 SFT
AREA OF CLINICAL BLOCK	26415.544 SFT
PLINTH AREA OF BLOCK	SFT

OPENING SCHEDULE OF DOORS AND WINDOWS					
DOORS	WIDTH	HEIGHT	WINDOWS	WIDTH	HEIGHT
D1	2'-0"	7'-0"	W1	3'-0"	5'-0"
D2	3'-6"	7'-0"	W2	4'-0"	4'-0"
D3	3'-0"	7'-0"	W3	6'-0"	6'-0"
D4	4'-0"	7'-0"	W4	8'-0"	12'-0"
D5	4'-6"	7'-0"	W5		
D6			W6		
D7			W7		
D8			V1	1'-6"	1'-6"
D9			V2		

Client:



GOVERNMENT OF THE PUNJAB  
PRIMARY & SECONDARY  
HEALTHCARE DEPARTMENT

Project:

CAD MAPPING OF TEHSIL  
HEAD QUARTER HOSPITALS,  
PUNJAB

Consultant:



SKAFS CONSULTANT (Pvt.) Limited  
ENGINEERING AND ENVIRONMENT CONSULTANT

Drawing Title:

THQ TANDIYAWALA  
HOSPITAL MASTER PLAN

Authorized By: SKAFS	Reviewed By Co-Team Leader	Scale: 1:400
-------------------------	-------------------------------	-----------------


Prepared By: CAD TEAMS	Date: FEB, 2017	
---------------------------	--------------------	--

Drawing No. SKAFS/TANDIYAWALA /03



# MASTER PLAN OF THQ HOSPITAL TANDIYAWALA

## PART 1

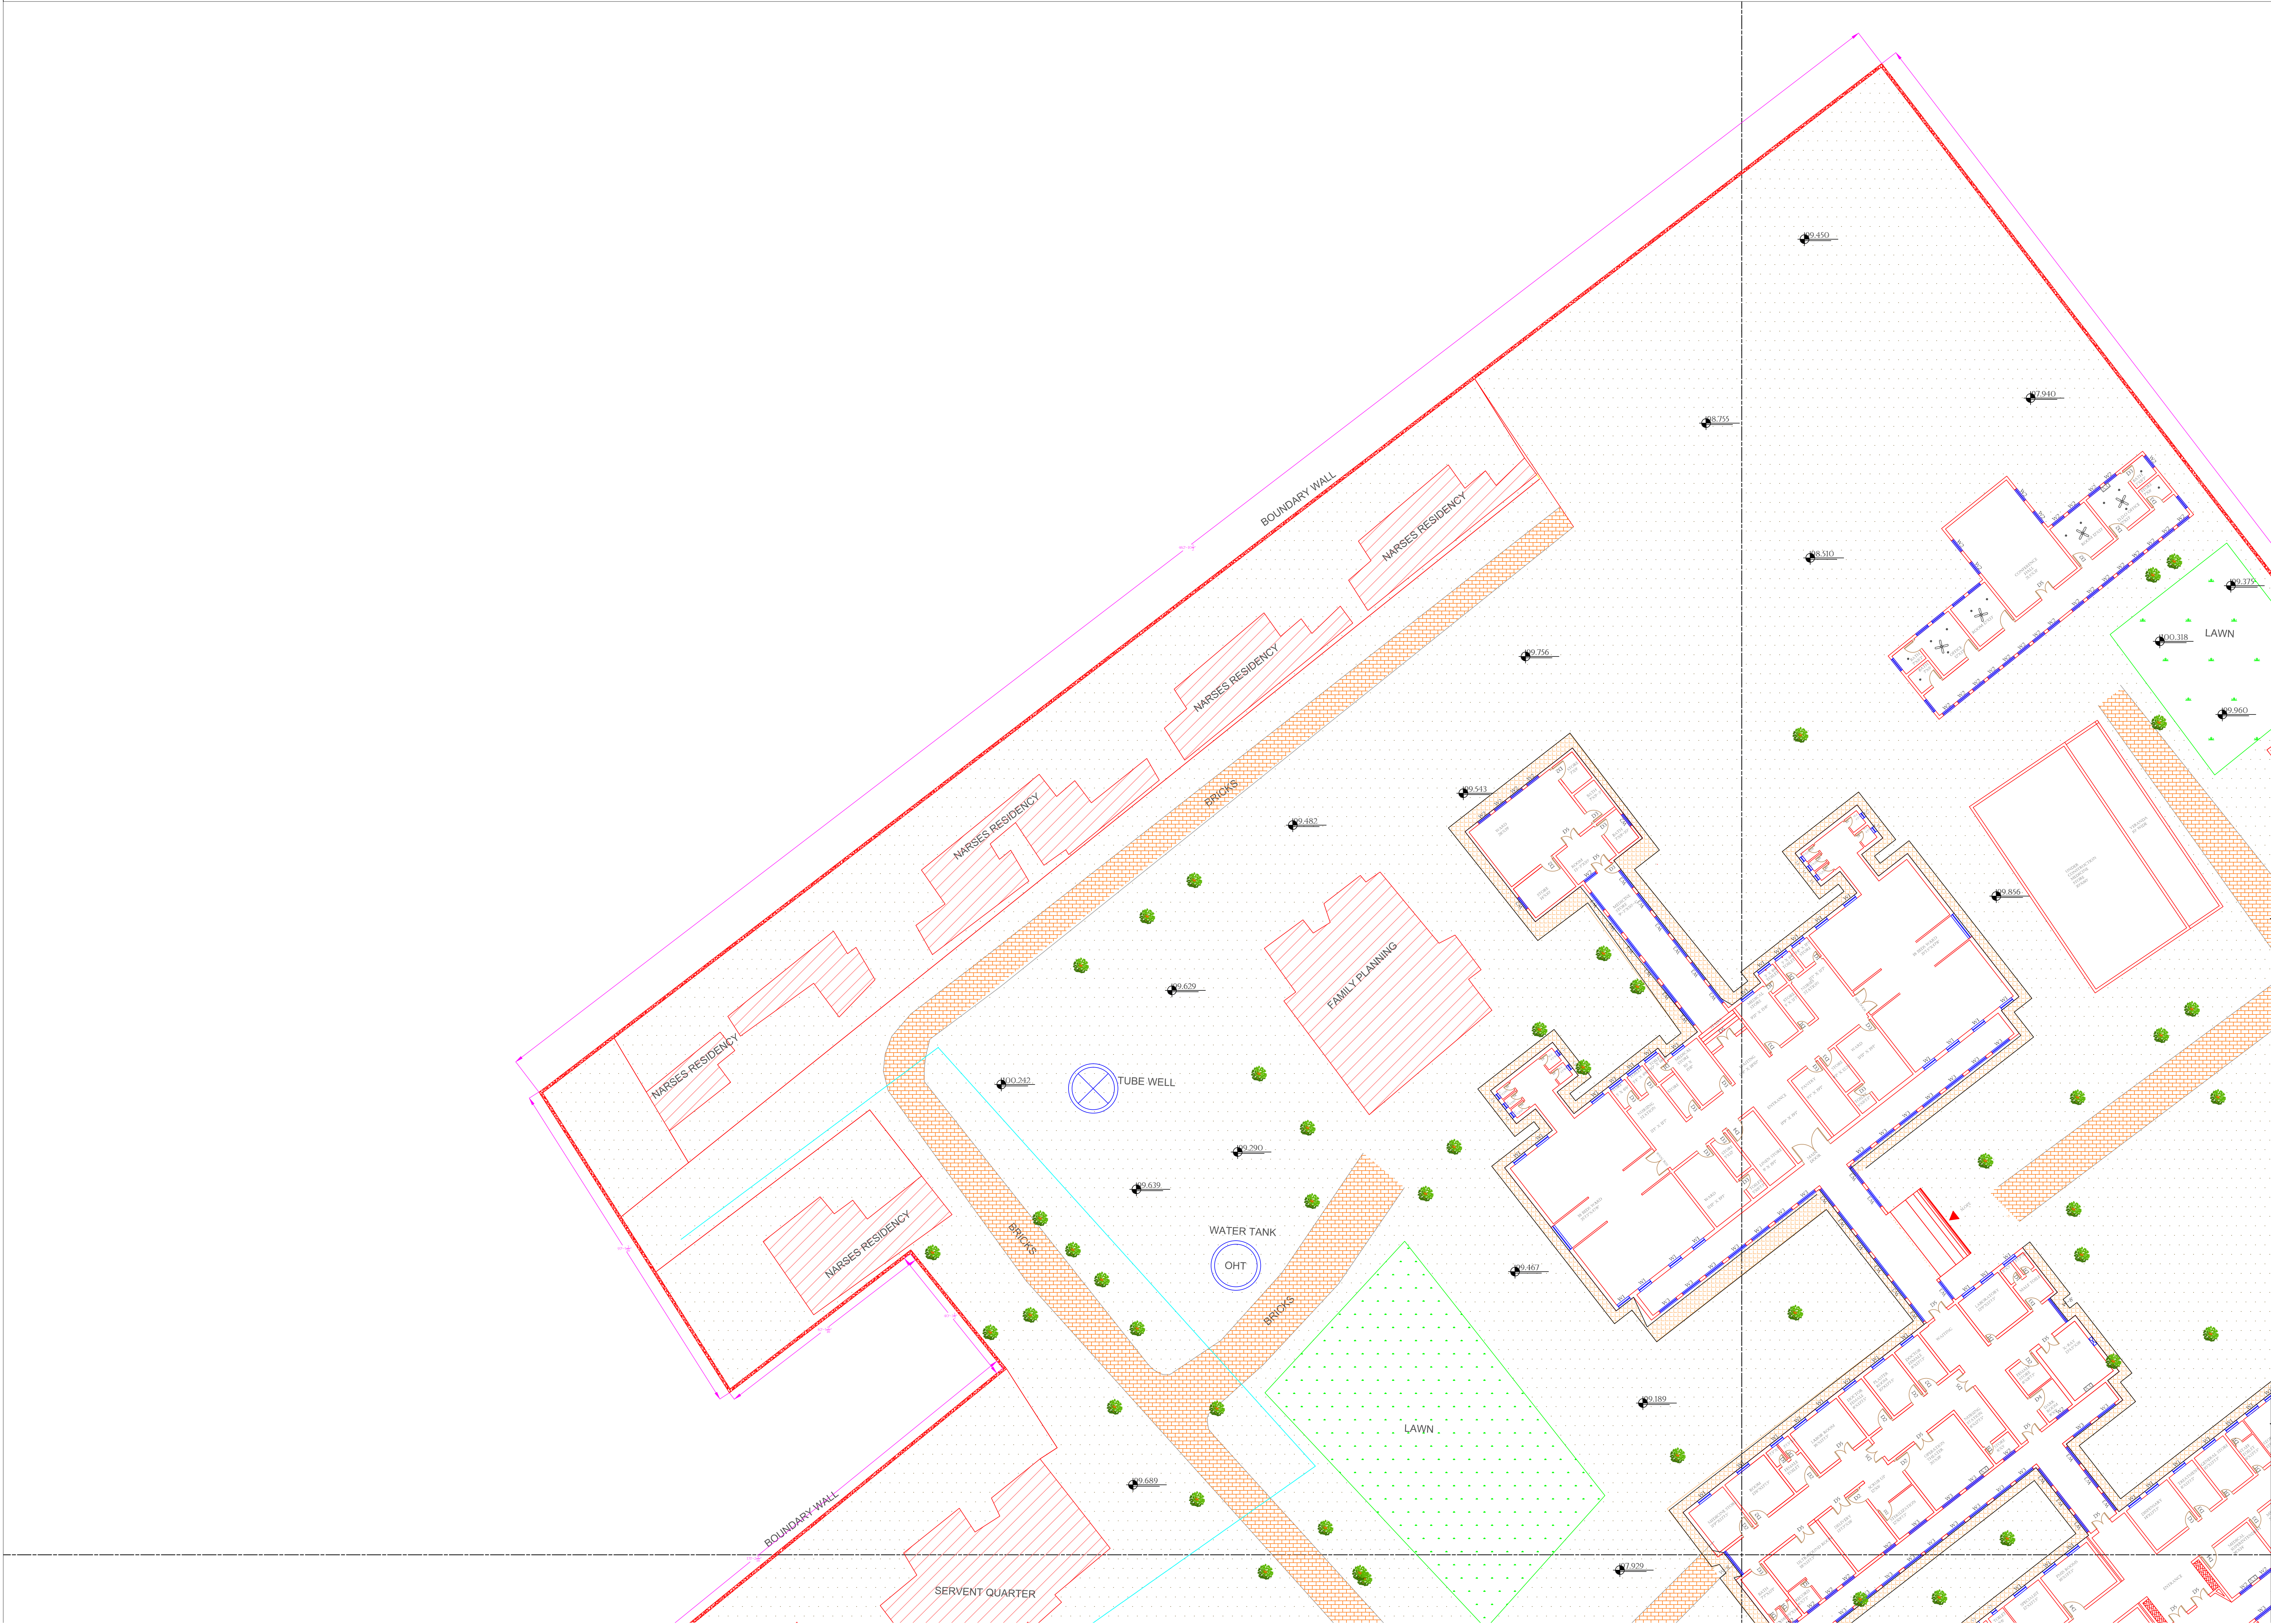

**Legends:**

RESIDENTIAL AREA	
ROAD	
WALL	
POWER LINE	
OHT	
TREE	
MANHOLE	
TUBE WELL	
LIGHT POLE	
LAWNS	
EARTHEN AREAS	
ASPHALTS ROADS	
TOUGH PAVERS	
P.C.C /PLINTH PROTECTION	
BOUNDARY WALL	
TAP	
HAND PUMP	
BRICK PAVERS	
AIR CONDITIONER	
TUBE LIGHT	
FAN	
ROOF LIGHT	
BULB	

AREA	
AREA WITHIN BOUNDARY WALL	287604.20 SFT
AREA OF CLINICAL BLOCK	26415.544 SFT
PLINTH AREA OF BLOCK	SFT

OPENING SCHEDULE OF DOORS AND WINDOWS					
DOORS	WIDTH	HEIGHT	WINDOWS	WIDTH	HEIGHT
D1	2'-0"	7'-0"	W1	3'-0"	5'-0"
D2	3'-6"	7'-0"	W2	4'-0"	4'-0"
D3	3'-0"	7'-0"	W3	6'-0"	6'-0"
D4	4'-0"	7'-0"	W4	8'-0"	12'-0"
D5	4'-6"	7'-0"	W5		
D6			W6		
D7			W7		
D8			V1	1'-6"	1'-6"
D9			V2		

Client:



GOVERNMENT OF THE PUNJAB  
PRIMARY & SECONDARY  
HEALTHCARE DEPARTMENT

Project:

CAD MAPPING OF TEHSIL  
HEAD QUARTER HOSPITALS,  
PUNJAB

Consultant:



SKAFS CONSULTANT (Pvt.) Limited  
ENGINEERING AND ENVIRONMENT CONSULTANT

Drawing Title:


THQ TANDIYAWALA  
HOSPITAL MASTER PLAN  
PART 1

Authorized By: SKAFS	Reviewed By: Co-Team Leader	Scale:
Prepared By: CAD TEAMS	Date: FEB, 2017	Sheet:
Drawing No.		SKAFS/TANDIYAWALA /04



# MASTER PLAN OF THQ HOSPITAL TANDIYAWALA

## PART 2

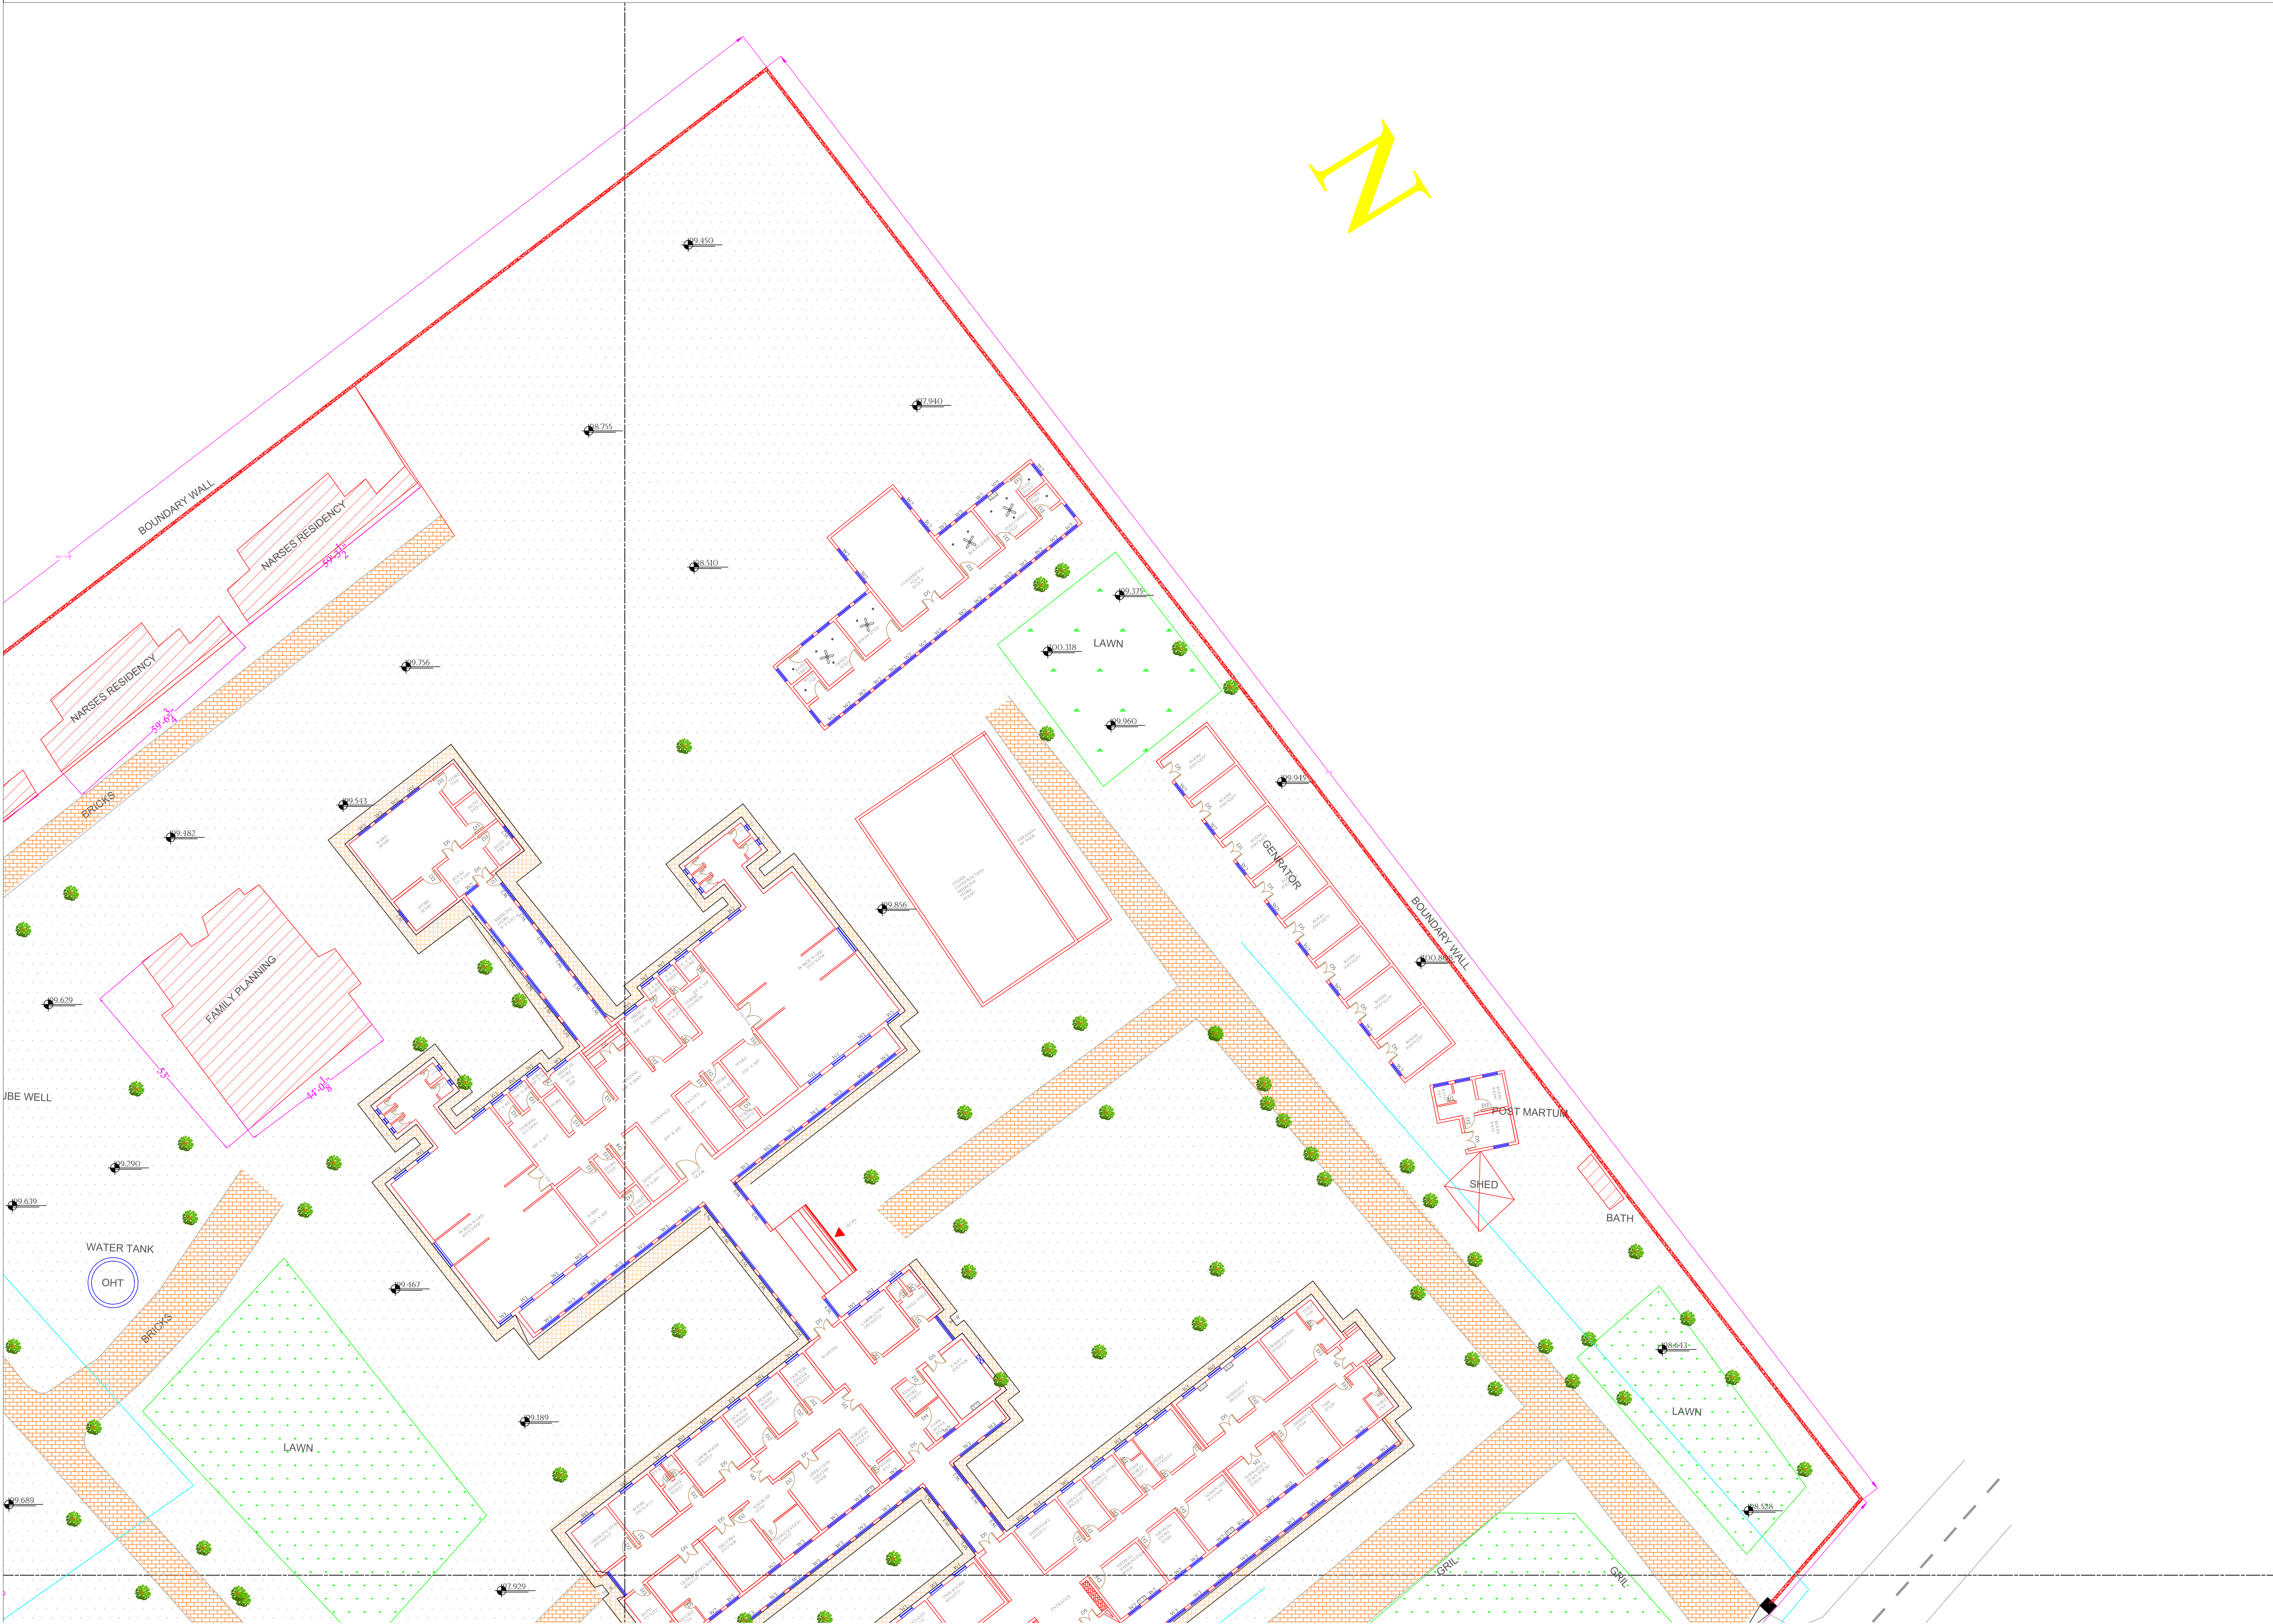

**Legends:**

RESIDENTIAL AREA	
ROAD	
WALL	
POWER LINE	
OHT	
TREE	
MANHOLE	
TUBE WELL	
LIGHT POLE	
LAWNS	
EARTHEN AREAS	
ASPHALTS ROADS	
TOUGH PAVERS	
P.C.C /PLINTH PROTECTION	
BOUNDARY WALL	
TAP	
HAND PUMP	
BRICK PAVERS	
AIR CONDITIONER	
TUBE LIGHT	
FAN	
ROOF LIGHT	
BULB	

AREA	
AREA WITHIN BOUNDARY WALL	287604.20 SFT
AREA OF CLINICAL BLOCK	26415.544 SFT
PLINTH AREA OF BLOCK	SFT

OPENING SCHEDULE OF DOORS AND WINDOWS					
DOORS	WIDTH	HEIGHT	WINDOWS	WIDTH	HEIGHT
D1	2'-0"	7'-0"	W1	3'-0"	5'-0"
D2	3'-6"	7'-0"	W2	4'-0"	4'-0"
D3	3'-0"	7'-0"	W3	6'-0"	6'-0"
D4	4'-0"	7'-0"	W4	8'-0"	12'-0"
D5	4'-6"	7'-0"	W5		
D6			W6		
D7			W7		
D8			V1	1'-6"	1'-6"
D9			V2		

Client:



GOVERNMENT OF THE PUNJAB  
PRIMARY & SECONDARY  
HEALTHCARE DEPARTMENT

Project:

**CAD MAPPING OF TEHSIL  
HEAD QUARTER HOSPITALS,  
PUNJAB**

Consultant:



**SKAFS CONSULTANT (Pvt.) Limited**  
ENGINEERING AND ENVIRONMENT CONSULTANT

Drawing Title:


**THQ TANDIYAWALA  
HOSPITAL MASTER PLAN  
PART 2**

Authorized By: SKAFS	Reviewed By Co-Team Leader	Scale:
Prepared By: CAD TEAMS	Date: FEB, 2017	Sheet:
Drawing No.		<b>SKAFS/TANDIYAWALA /05</b>



# MASTER PLAN OF THQ HOSPITAL TANDIYAWALA

## PART 3

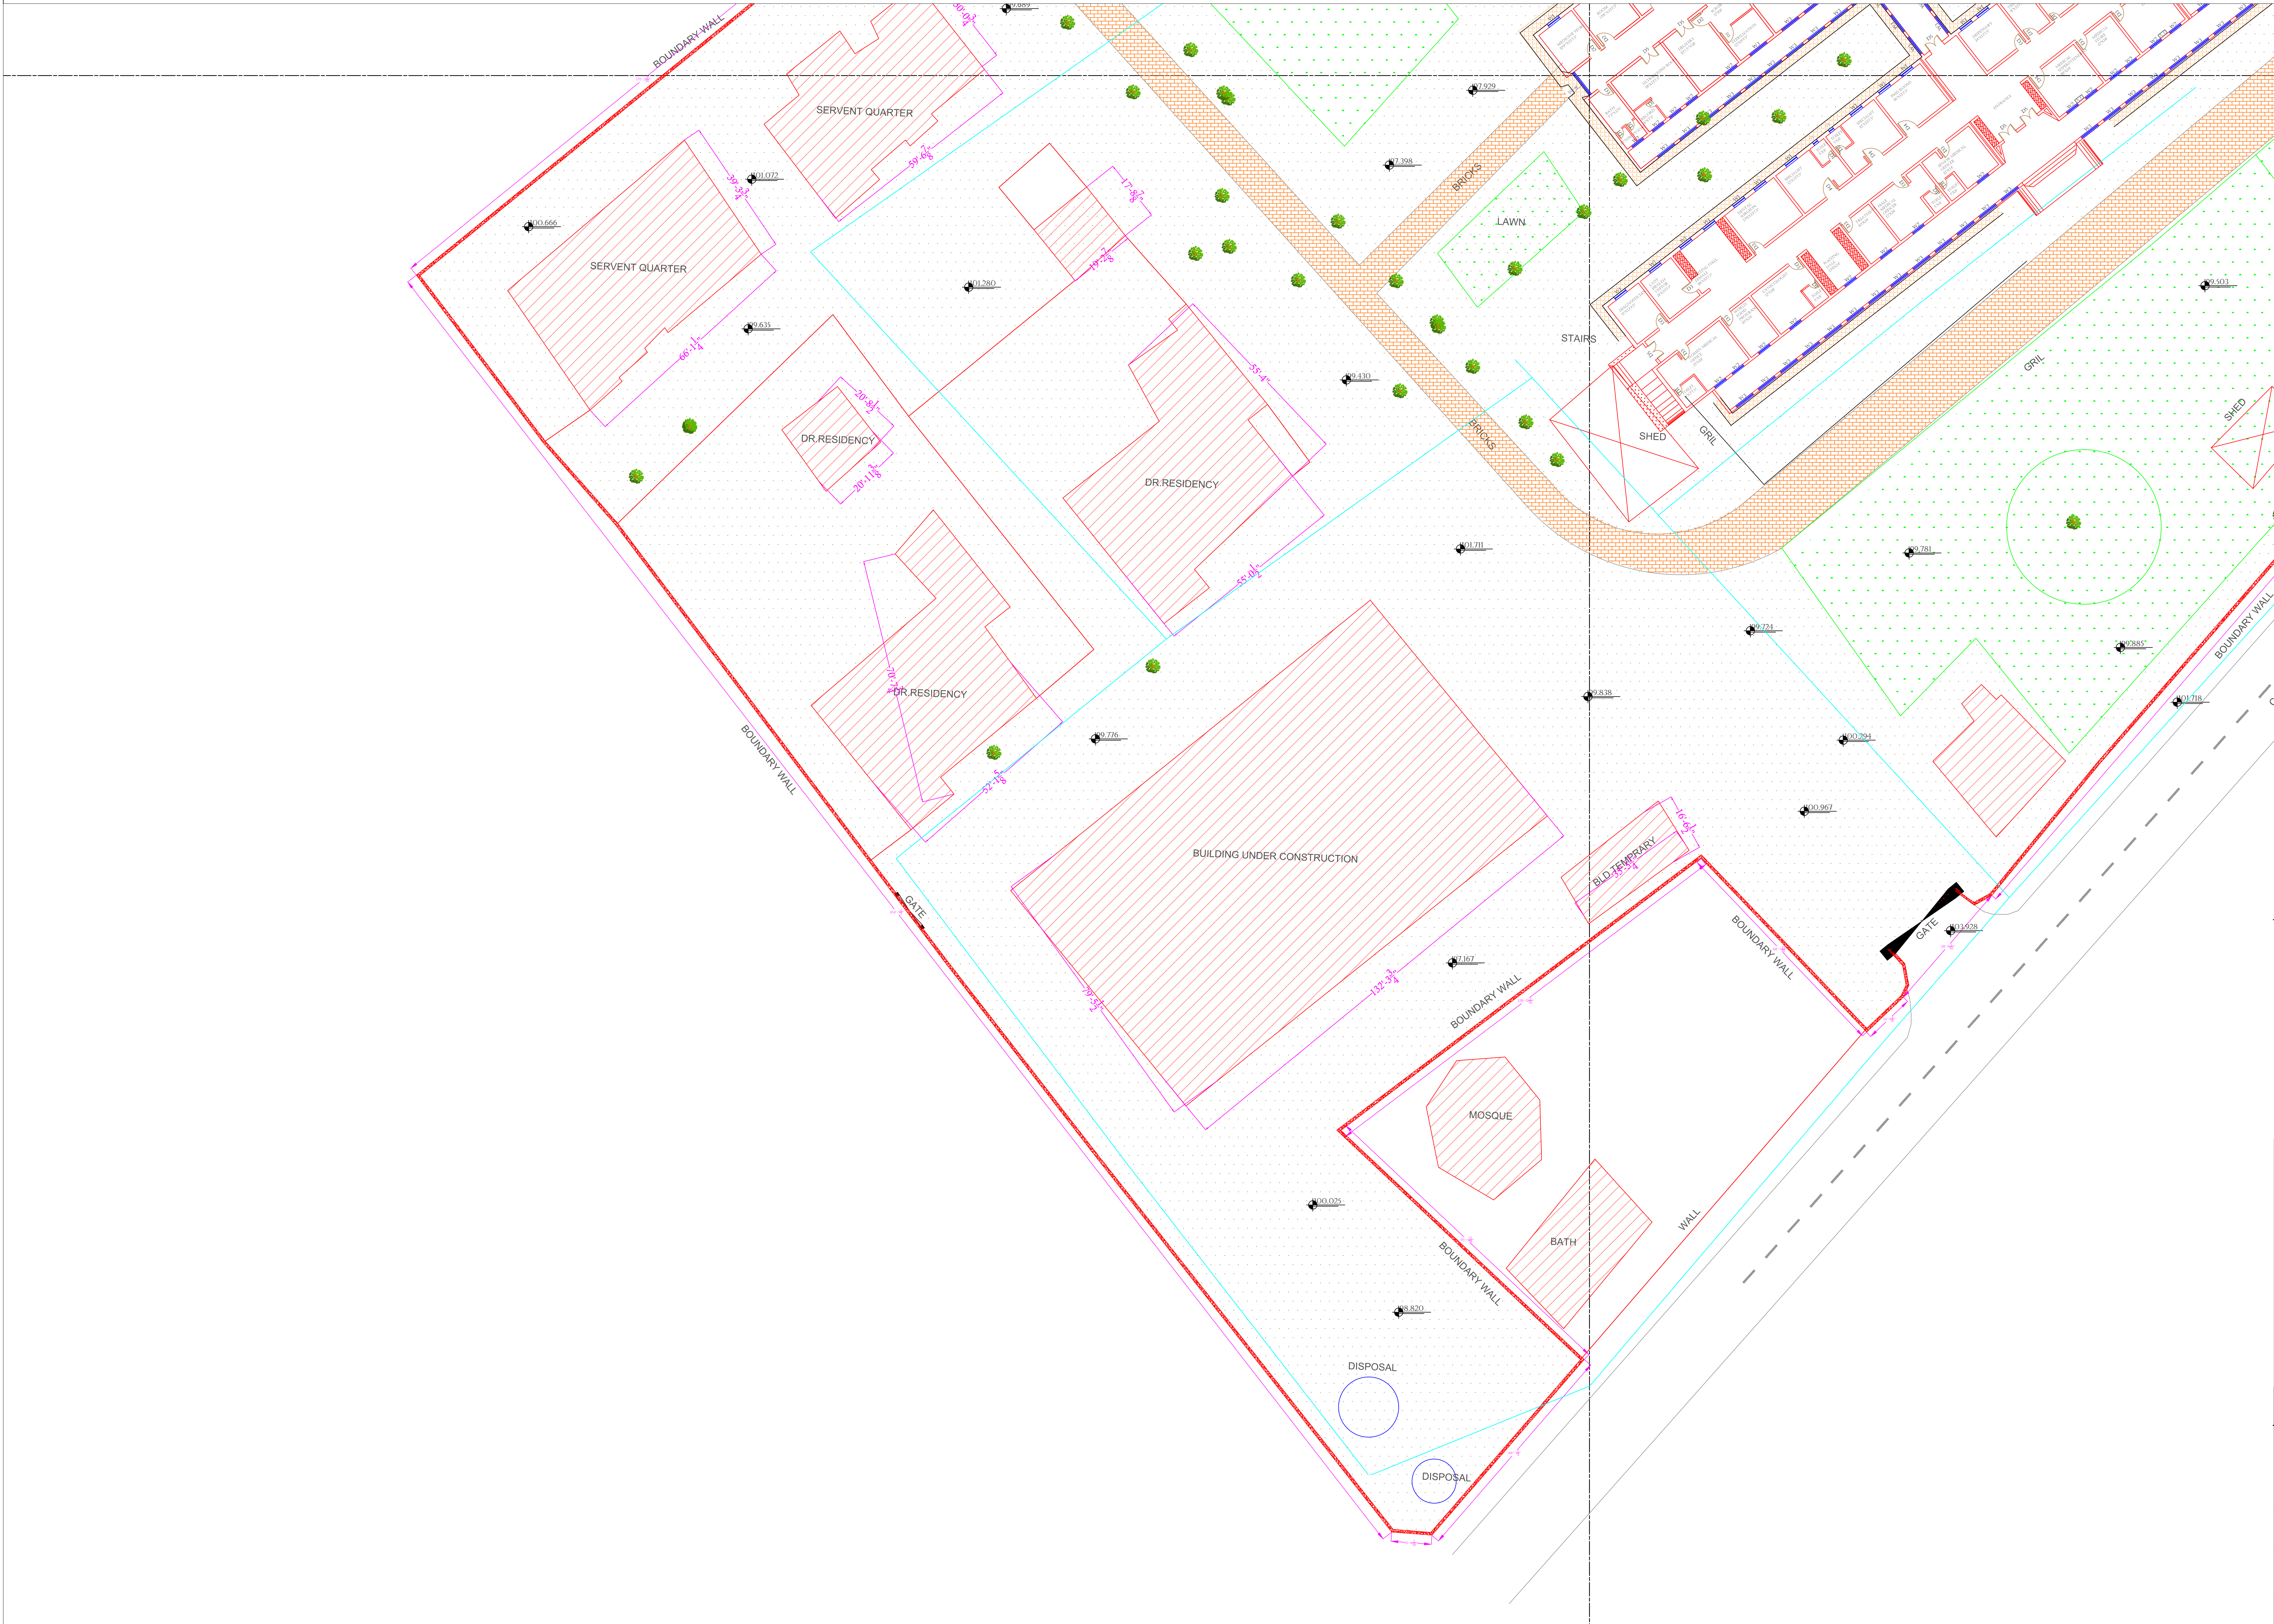

**Legends:**

RESIDENTIAL AREA	
ROAD	
WALL	
POWER LINE	
OHT	
TREE	
MANHOLE	
TUBE WELL	
LIGHT POLE	
LAWNS	
EARTHEN AREAS	
ASPHALTS ROADS	
TOUGH PAVERS	
P.C.C /PLINTH PROTECTION	
BOUNDARY WALL	
TAP	
HAND PUMP	
BRICK PAVERS	
AIR CONDITIONER	
TUBE LIGHT	
FAN	
ROOF LIGHT	
BULB	

AREA	
AREA WITHIN BOUNDARY WALL	287604.20 SFT
AREA OF CLINICAL BLOCK	26415.544 SFT
PLINTH AREA OF BLOCK	SFT

OPENING SCHEDULE OF DOORS AND WINDOWS					
DOORS	WIDTH	HEIGHT	WINDOWS	WIDTH	HEIGHT
D1	2'-0"	7'-0"	W1	3'-0"	5'-0"
D2	3'-6"	7'-0"	W2	4'-0"	4'-0"
D3	3'-0"	7'-0"	W3	6'-0"	6'-0"
D4	4'-0"	7'-0"	W4	8'-0"	12'-0"
D5	4'-6"	7'-0"	W5		
D6			W6		
D7			W7		
D8			V1	1'-6"	1'-6"
D9			V2		

Client:

GOVERNMENT OF THE PUNJAB  
PRIMARY & SECONDARY  
HEALTHCARE DEPARTMENT

Project:

CAD MAPPING OF TEHSIL  
HEAD QUARTER HOSPITALS,  
PUNJAB

Consultant:

SKAFS CONSULTANT (Pvt.) Limited  
ENGINEERING AND ENVIRONMENT CONSULTANT

Drawing Title:

THQ TANDIYAWALA  
HOSPITAL MASTER PLAN  
PART 3

Authorized By: SKAFS	Reviewed By Co-Team Leader	Scale:
Prepared By: CAD TEAMS	Date: FEB, 2017	


Drawing No.

SKAFS/TANDIYAWALA /06



# MASTER PLAN OF THQ HOSPITAL TANDIYAWALA

## PART 4

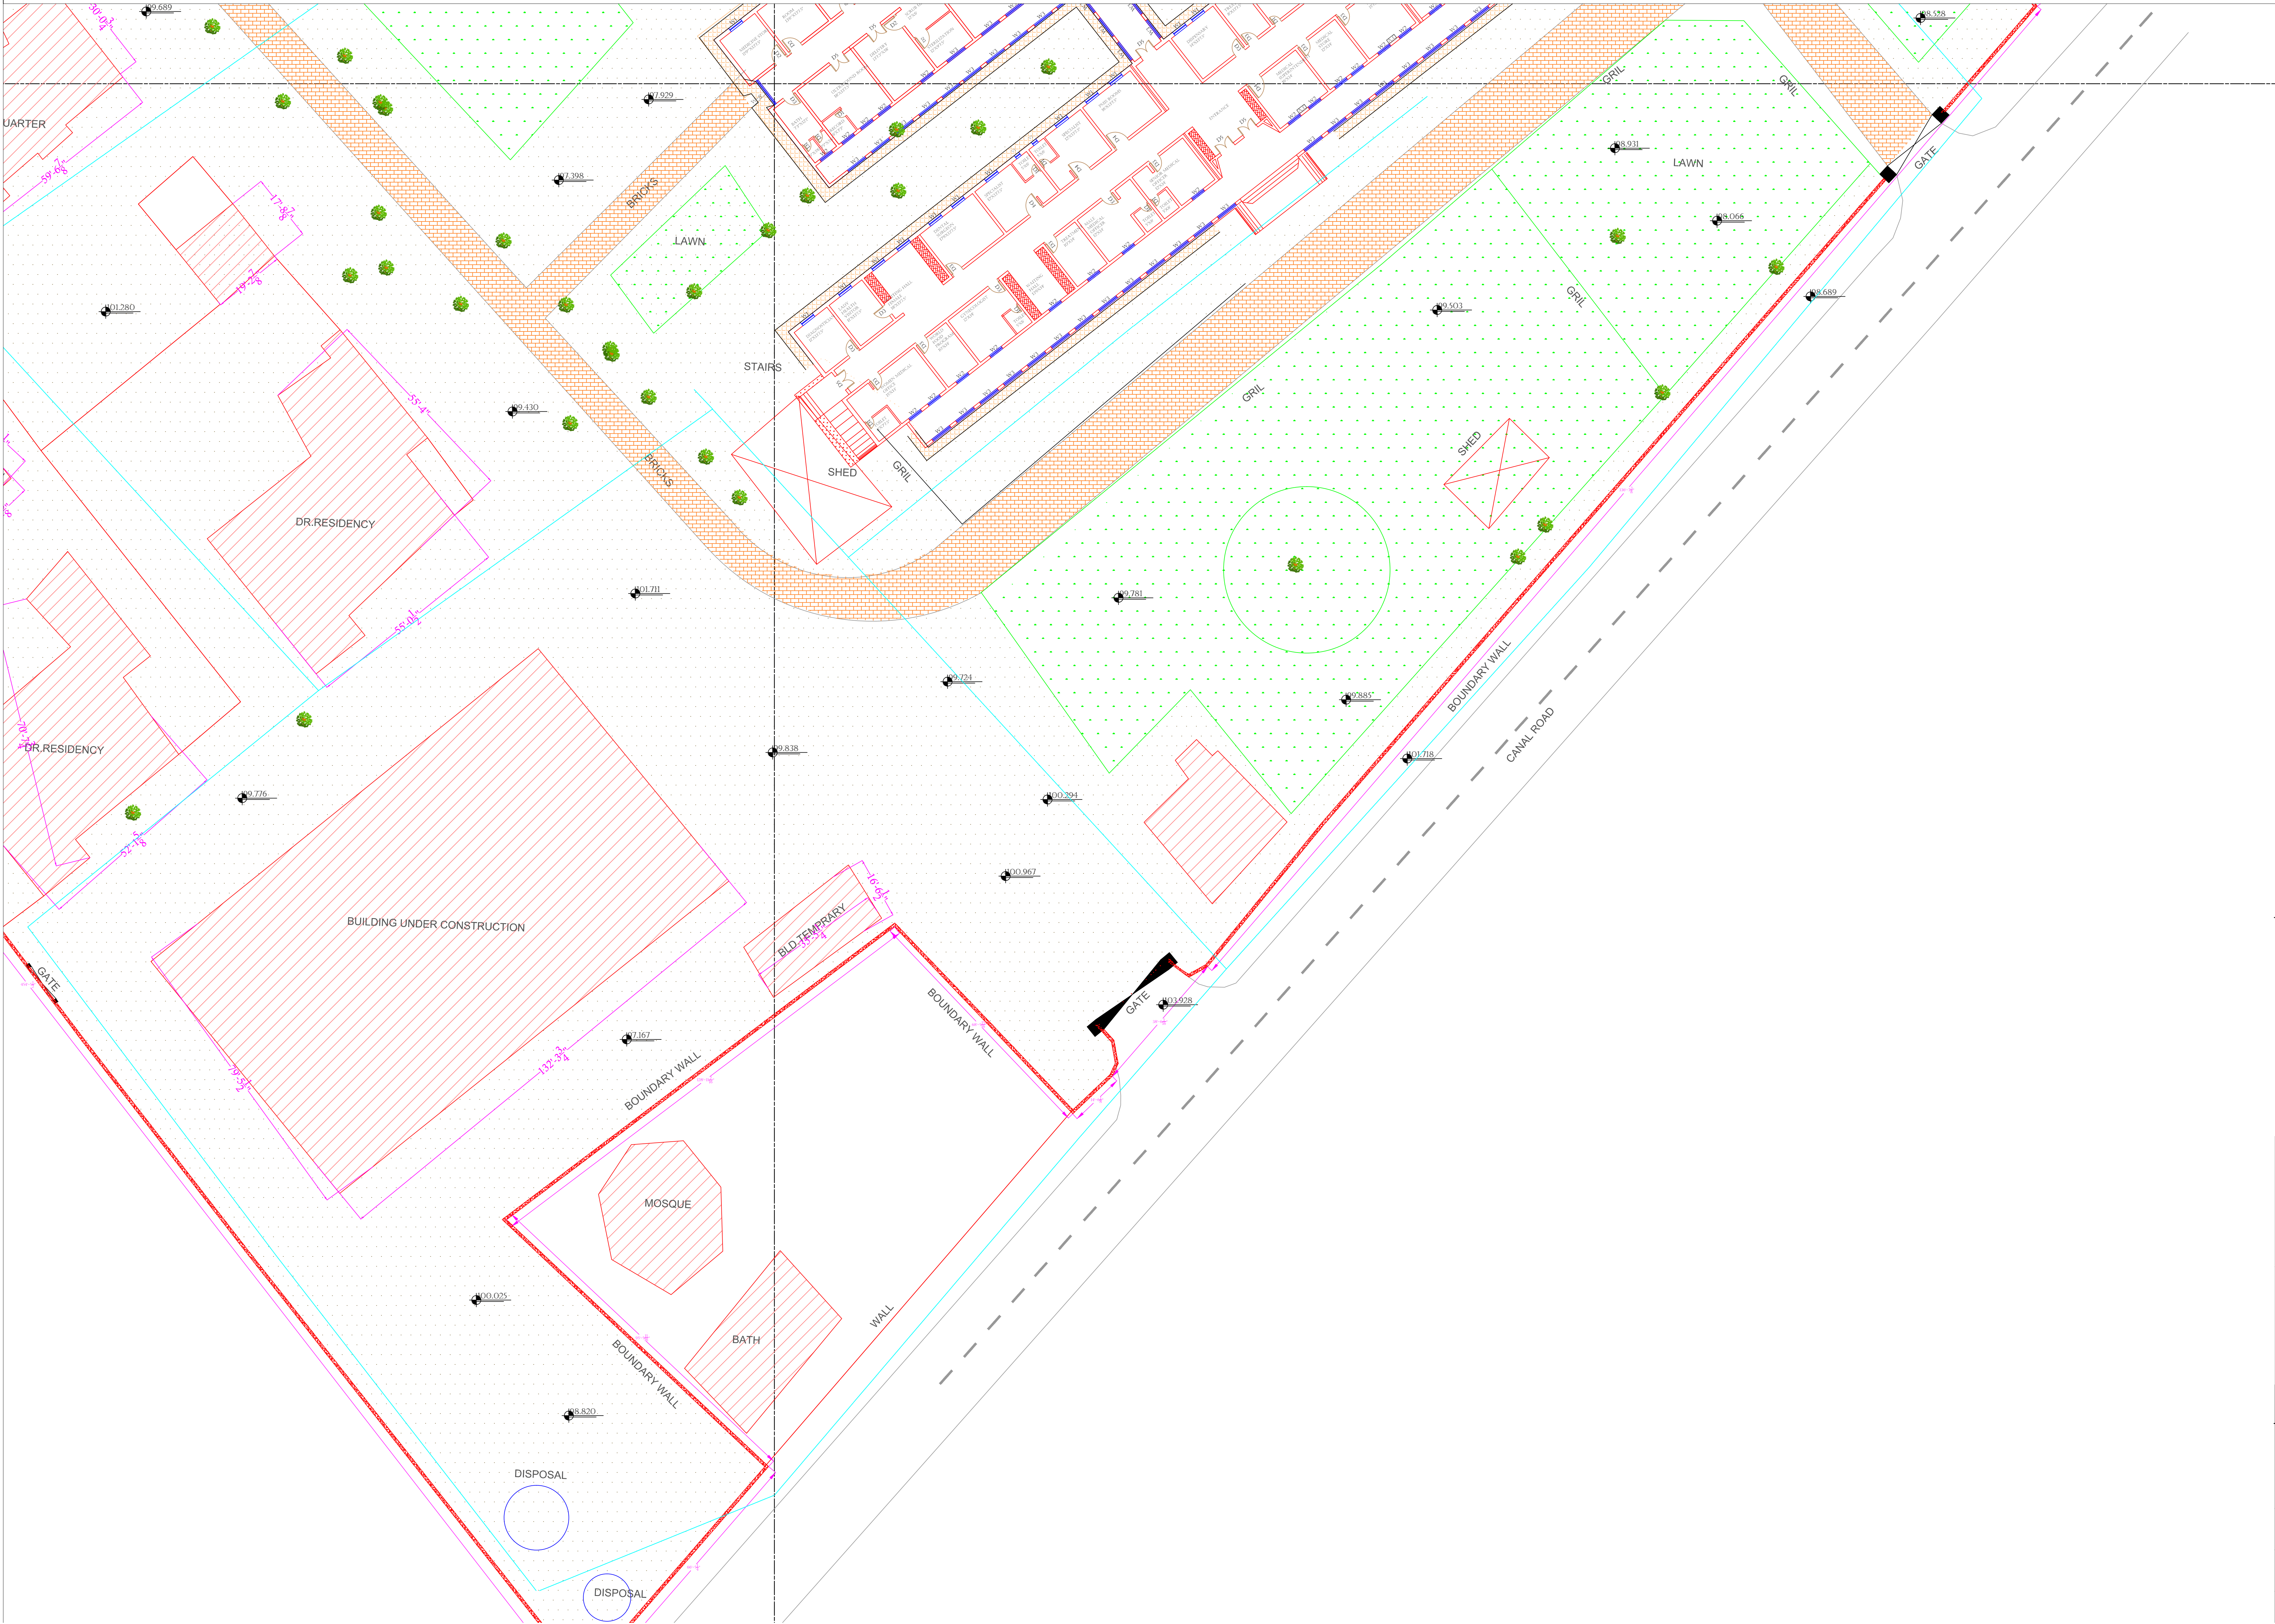

**Legends:**

RESIDENTIAL AREA	
ROAD	
WALL	
POWER LINE	
OHT	
TREE	
MANHOLE	
TUBE WELL	
LIGHT POLE	
LAWNS	
EARTHEN AREAS	
ASPHALTS ROADS	
TOUGH PAVERS	
P.C.C /PLINTH PROTECTION	
BOUNDARY WALL	
TAP	
HAND PUMP	
BRICK PAVERS	
AIR CONDITIONER	
TUBE LIGHT	
FAN	
ROOF LIGHT	
BULB	

AREA	
AREA WITHIN BOUNDARY WALL	287604.20 SFT
AREA OF CLINICAL BLOCK	26415.544 SFT
PLINTH AREA OF BLOCK	SFT

OPENING SCHEDULE OF DOORS AND WINDOWS					
DOORS	WIDTH	HEIGHT	WINDOWS	WIDTH	HEIGHT
D1	2'-0"	7'-0"	W1	3'-0"	5'-0"
D2	3'-6"	7'-0"	W2	4'-0"	4'-0"
D3	3'-0"	7'-0"	W3	6'-0"	6'-0"
D4	4'-0"	7'-0"	W4	8'-0"	12'-0"
D5	4'-6"	7'-0"	W5		
D6			W6		
D7			W7		
D8			V1	1'-6"	1'-6"
D9			V2		

Client:



GOVERNMENT OF THE PUNJAB  
PRIMARY & SECONDARY  
HEALTHCARE DEPARTMENT

Project:

**CAD MAPPING OF TEHSIL  
HEAD QUARTER HOSPITALS,  
PUNJAB**

Consultant:



**SKAFS CONSULTANT (Pvt.) Limited**  
ENGINEERING AND ENVIRONMENT CONSULTANT

Drawing Title:

**THQ TANDIYAWALA  
HOSPITAL MASTER PLAN  
PART 4**

Authorized By: SKAFS	Reviewed By: Co-Team Leader	Scale:
Prepared By: CAD TEAMS	Date: FEB, 2017	
Drawing No.		SKAFS/TANDIYAWALA /07








# CLINICAL BLOCK OF THQ HOSPITAL TANDIYAWALA

## GROUND FLOOR (PART 1)

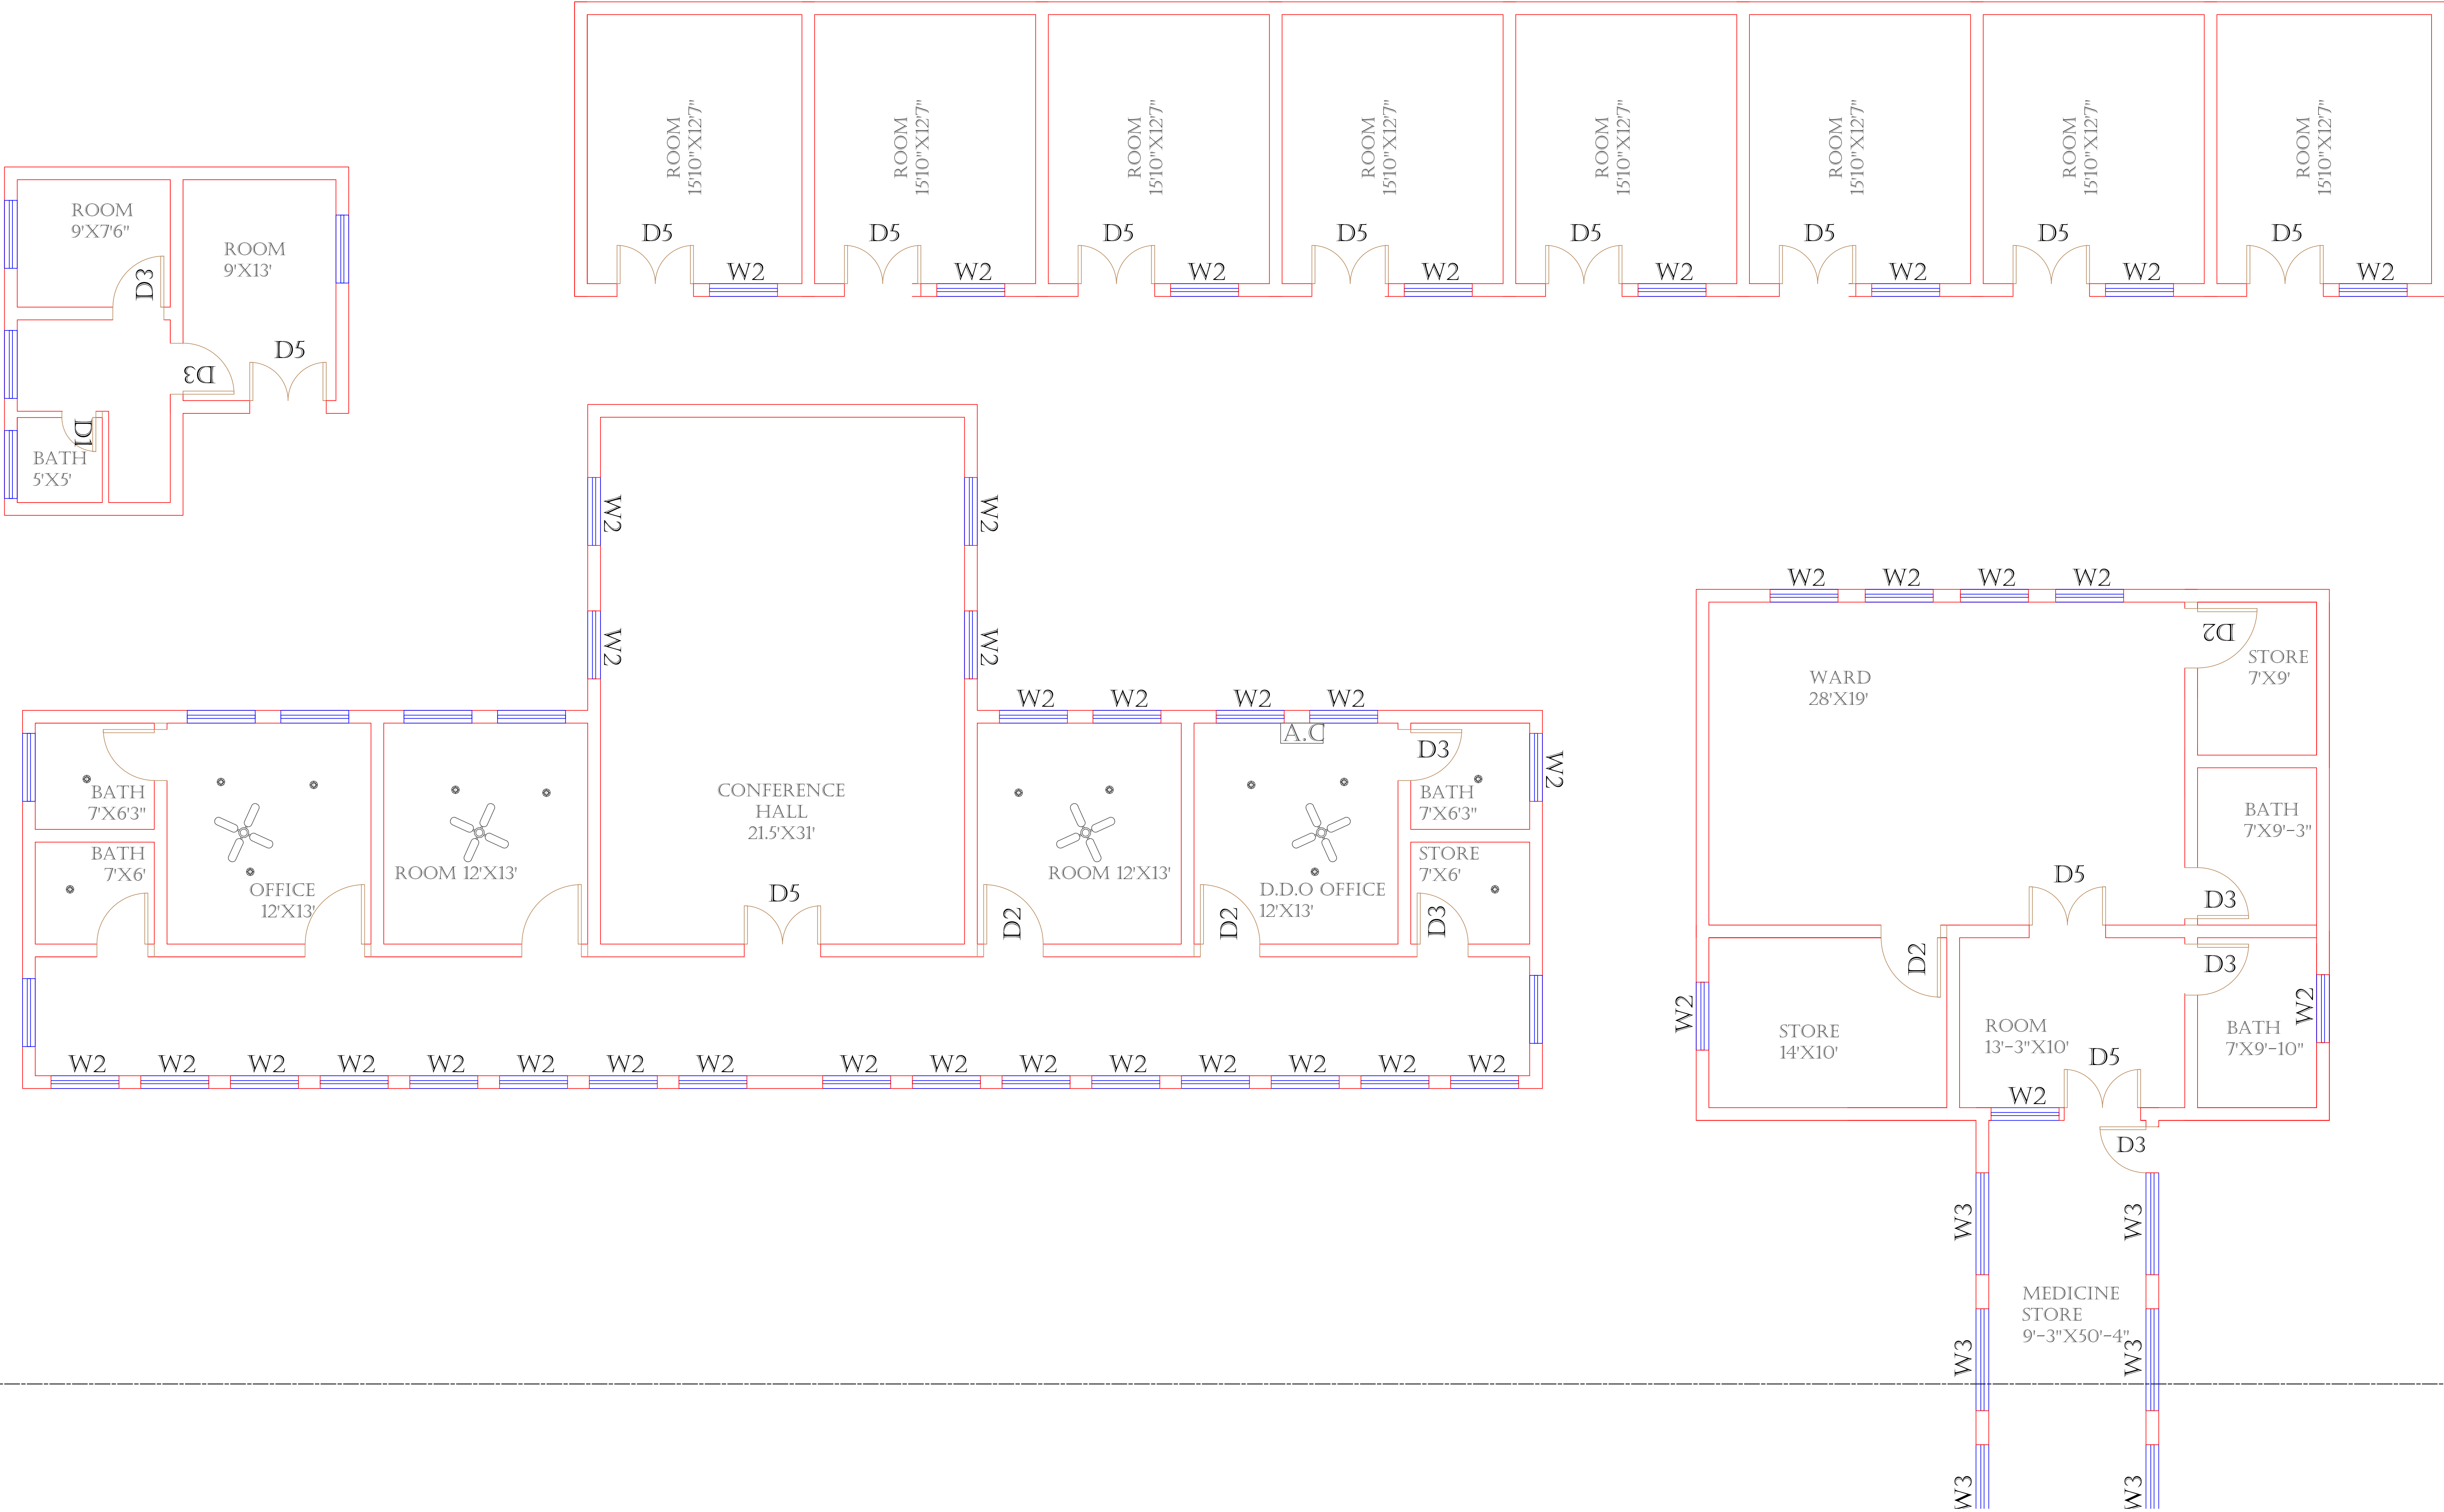


**Legends:**

RESIDENTIAL AREA	
ROAD	
WALL	
POWER LINE	
OHT	
TREE	
MANHOLE	
TUBE WELL	
LIGHT POLE	
LAWNS	
EARTHEN AREAS	
ASPHALTS ROADS	
TOUGH PAVERS	
P.C.C /PLINTH PROTECTION	
BOUNDARY WALL	
TAP	
HAND PUMP	
BRICK PAVERS	
AIR CONDITIONER	
TUBE LIGHT	
FAN	
ROOF LIGHT	
BULB	

AREA	
AREA WITHIN BOUNDARY WALL	287604.20 SFT
AREA OF CLINICAL BLOCK	26415.544 SFT
PLINTH AREA OF BLOCK	SFT

OPENING SCHEDULE OF DOORS AND WINDOWS					
DOORS	WIDTH	HEIGHT	WINDOWS	WIDTH	HEIGHT
D1	2'-0"	7'-0"	W1	3'-0"	5'-0"
D2	3'-6"	7'-0"	W2	4'-0"	4'-0"
D3	3'-0"	7'-0"	W3	6'-0"	6'-0"
D4	4'-0"	7'-0"	W4	8'-0"	12'-0"
D5	4'-6"	7'-0"	W5		
D6			W6		
D7			W7		
D8			V1	1'-6"	1'-6"
D9			V2		


Client:

  
**GOVERNMENT OF THE PUNJAB  
PRIMARY & SECONDARY  
HEALTHCARE DEPARTMENT**

Project:

**CAD MAPPING OF TEHSIL  
HEAD QUARTER HOSPITALS,  
PUNJAB**

Consultant:

  
**SKAFS CONSULTANT (Pvt.) Limited**  
ENGINEERING AND ENVIRONMENT CONSULTANT


Drawing Title:





 




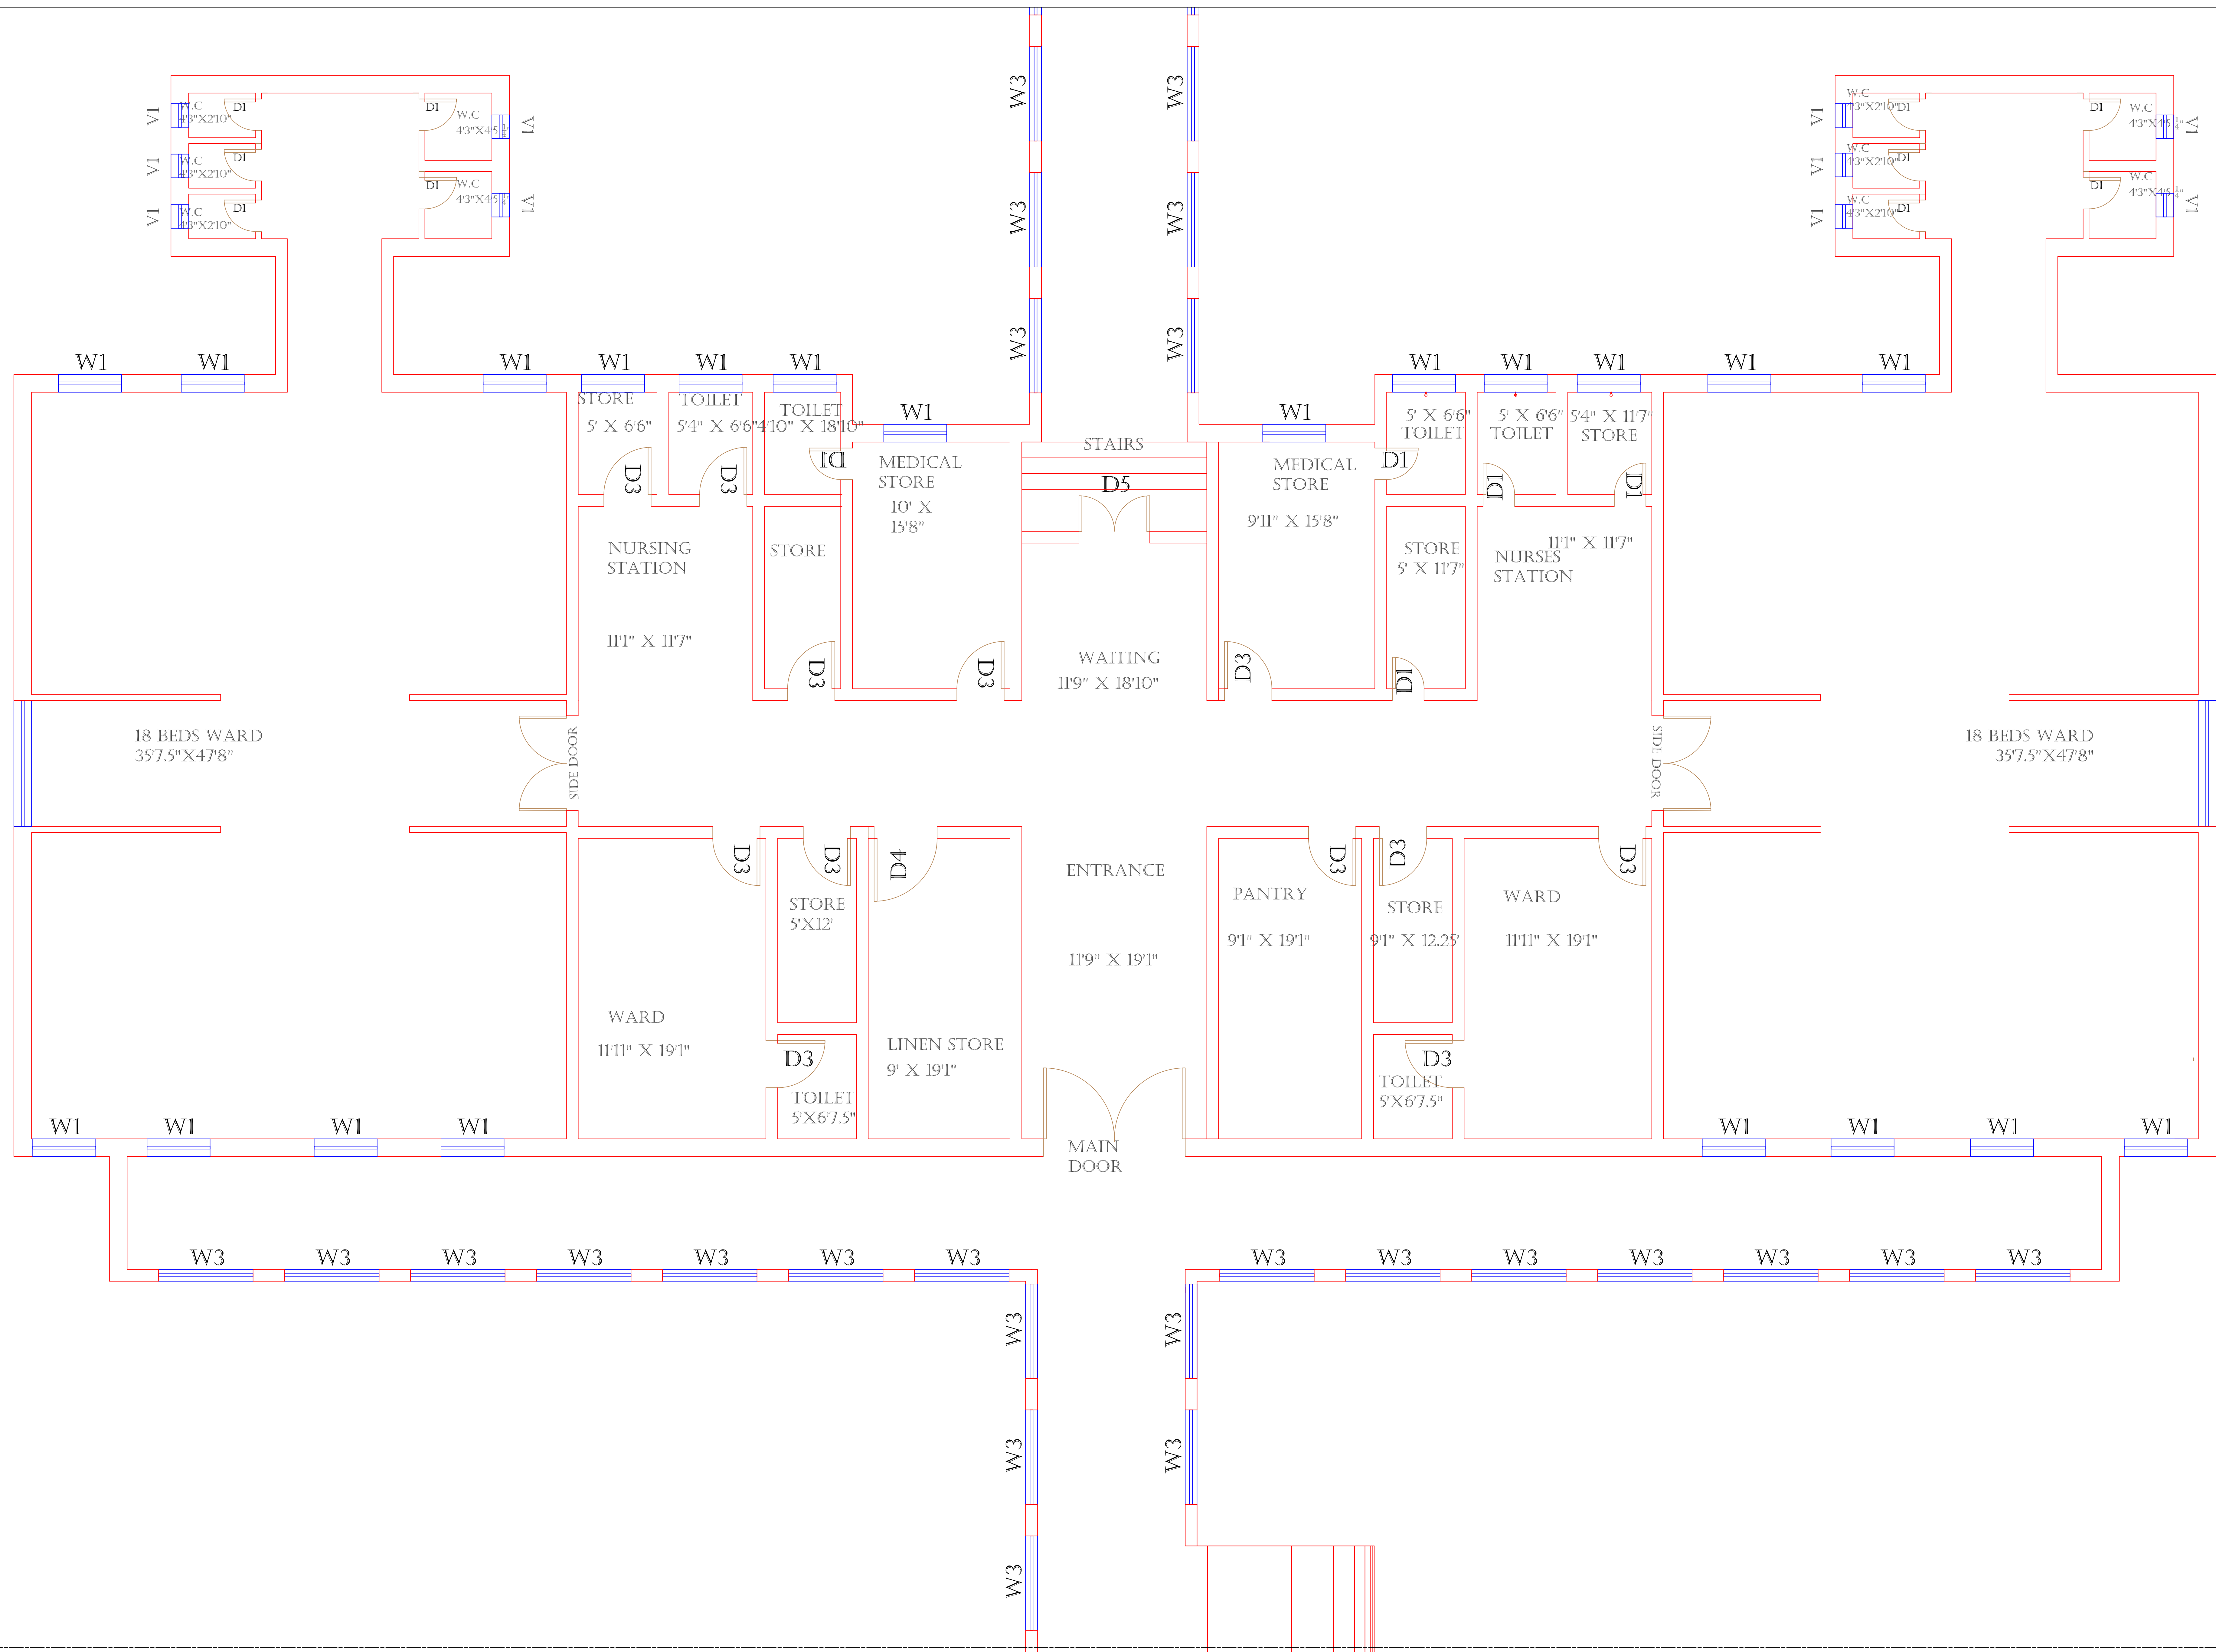













**THQ TANDIYAWALA  
HOSPITAL CLINICAL BLOCK  
PART 1**

Authorized By: SKAFS	Reviewed By Co-Team Leader	Scale:
Prepared By: CAD TEAMS	Date: FEB, 2017	
Drawing No.		<b>SKAFS/TANDIYAWALA /09</b>

 

 CLINICAL BLOCK OF THQ HOSPITAL TANDIYAWALA  
GROUND FLOOR (PART 2)



Legends:	
RESIDENTIAL AREA	
ROAD	
WALL	
POWER LINE	
OHT	
TREE	
MANHOLE	
TUBE WELL	
LIGHT POLE	
LAWNS	
EARTHEN AREAS	
ASPHALT'S ROADS	
TOUGH PAVERS	
P.C.C /PLINTH PROTECTION	
BOUNDARY WALL	
TAP	
HAND PUMP	
BRICK PAVERS	
AIR CONDITIONER	
TUBE LIGHT	
FAN	
ROOF LIGHT	
BULB	

AREA	
AREA WITHIN BOUNDARY WALL	287604.20 SFT
AREA OF CLINICAL BLOCK	26415.544 SFT
PLINTH AREA OF BLOCK	SFT

OPENING SCHEDULE OF DOORS AND WINDOWS					
DOORS	WIDTH	HEIGHT	WINDOWS	WIDTH	HEIGHT
D1	2'-0"	7'-0"	W1	3'-0"	5'-0"
D2	3'-6"	7'-0"	W2	4'-0"	4'-0"
D3	3'-0"	7'-0"	W3	6'-0"	6'-0"
D4	4'-0"	7'-0"	W4	8'-0"	12'-0"
D5	4'-6"	7'-0"	W5		
D6			W6		
D7			W7		
D8			V1	1'-6"	1'-6"
D9			V2		

Client: \_\_\_\_\_



GOVERNMENT OF THE PUNJAB  
PRIMARY & SECONDARY  
HEALTHCARE DEPARTMENT

Project:

## CAD MAPPING OF TEHSIL HEAD QUARTER HOSPITALS, PUNJAB

Consultant:



**SKAFS CONSULTANT (Pvt.) Limited**  
ENGINEERING AND ENVIRONMENT CONSULTANT

Drawing Title:  
**THQ TANDIYAWALA  
HOSPITAL CLINICAL BLOCK  
PART 2**


Authorized By: SKAFS	Reviewed By Co-Team Leader	Scale:
Prepared By: CAD TEAMS	Date: FEB, 2017	

Drawing No. **SKAFS/TANDIYAWALA /10**



# CLINICAL BLOCK OF THQ HOSPITAL TANDIYAWALA

## GROUND FLOOR (PART 3)

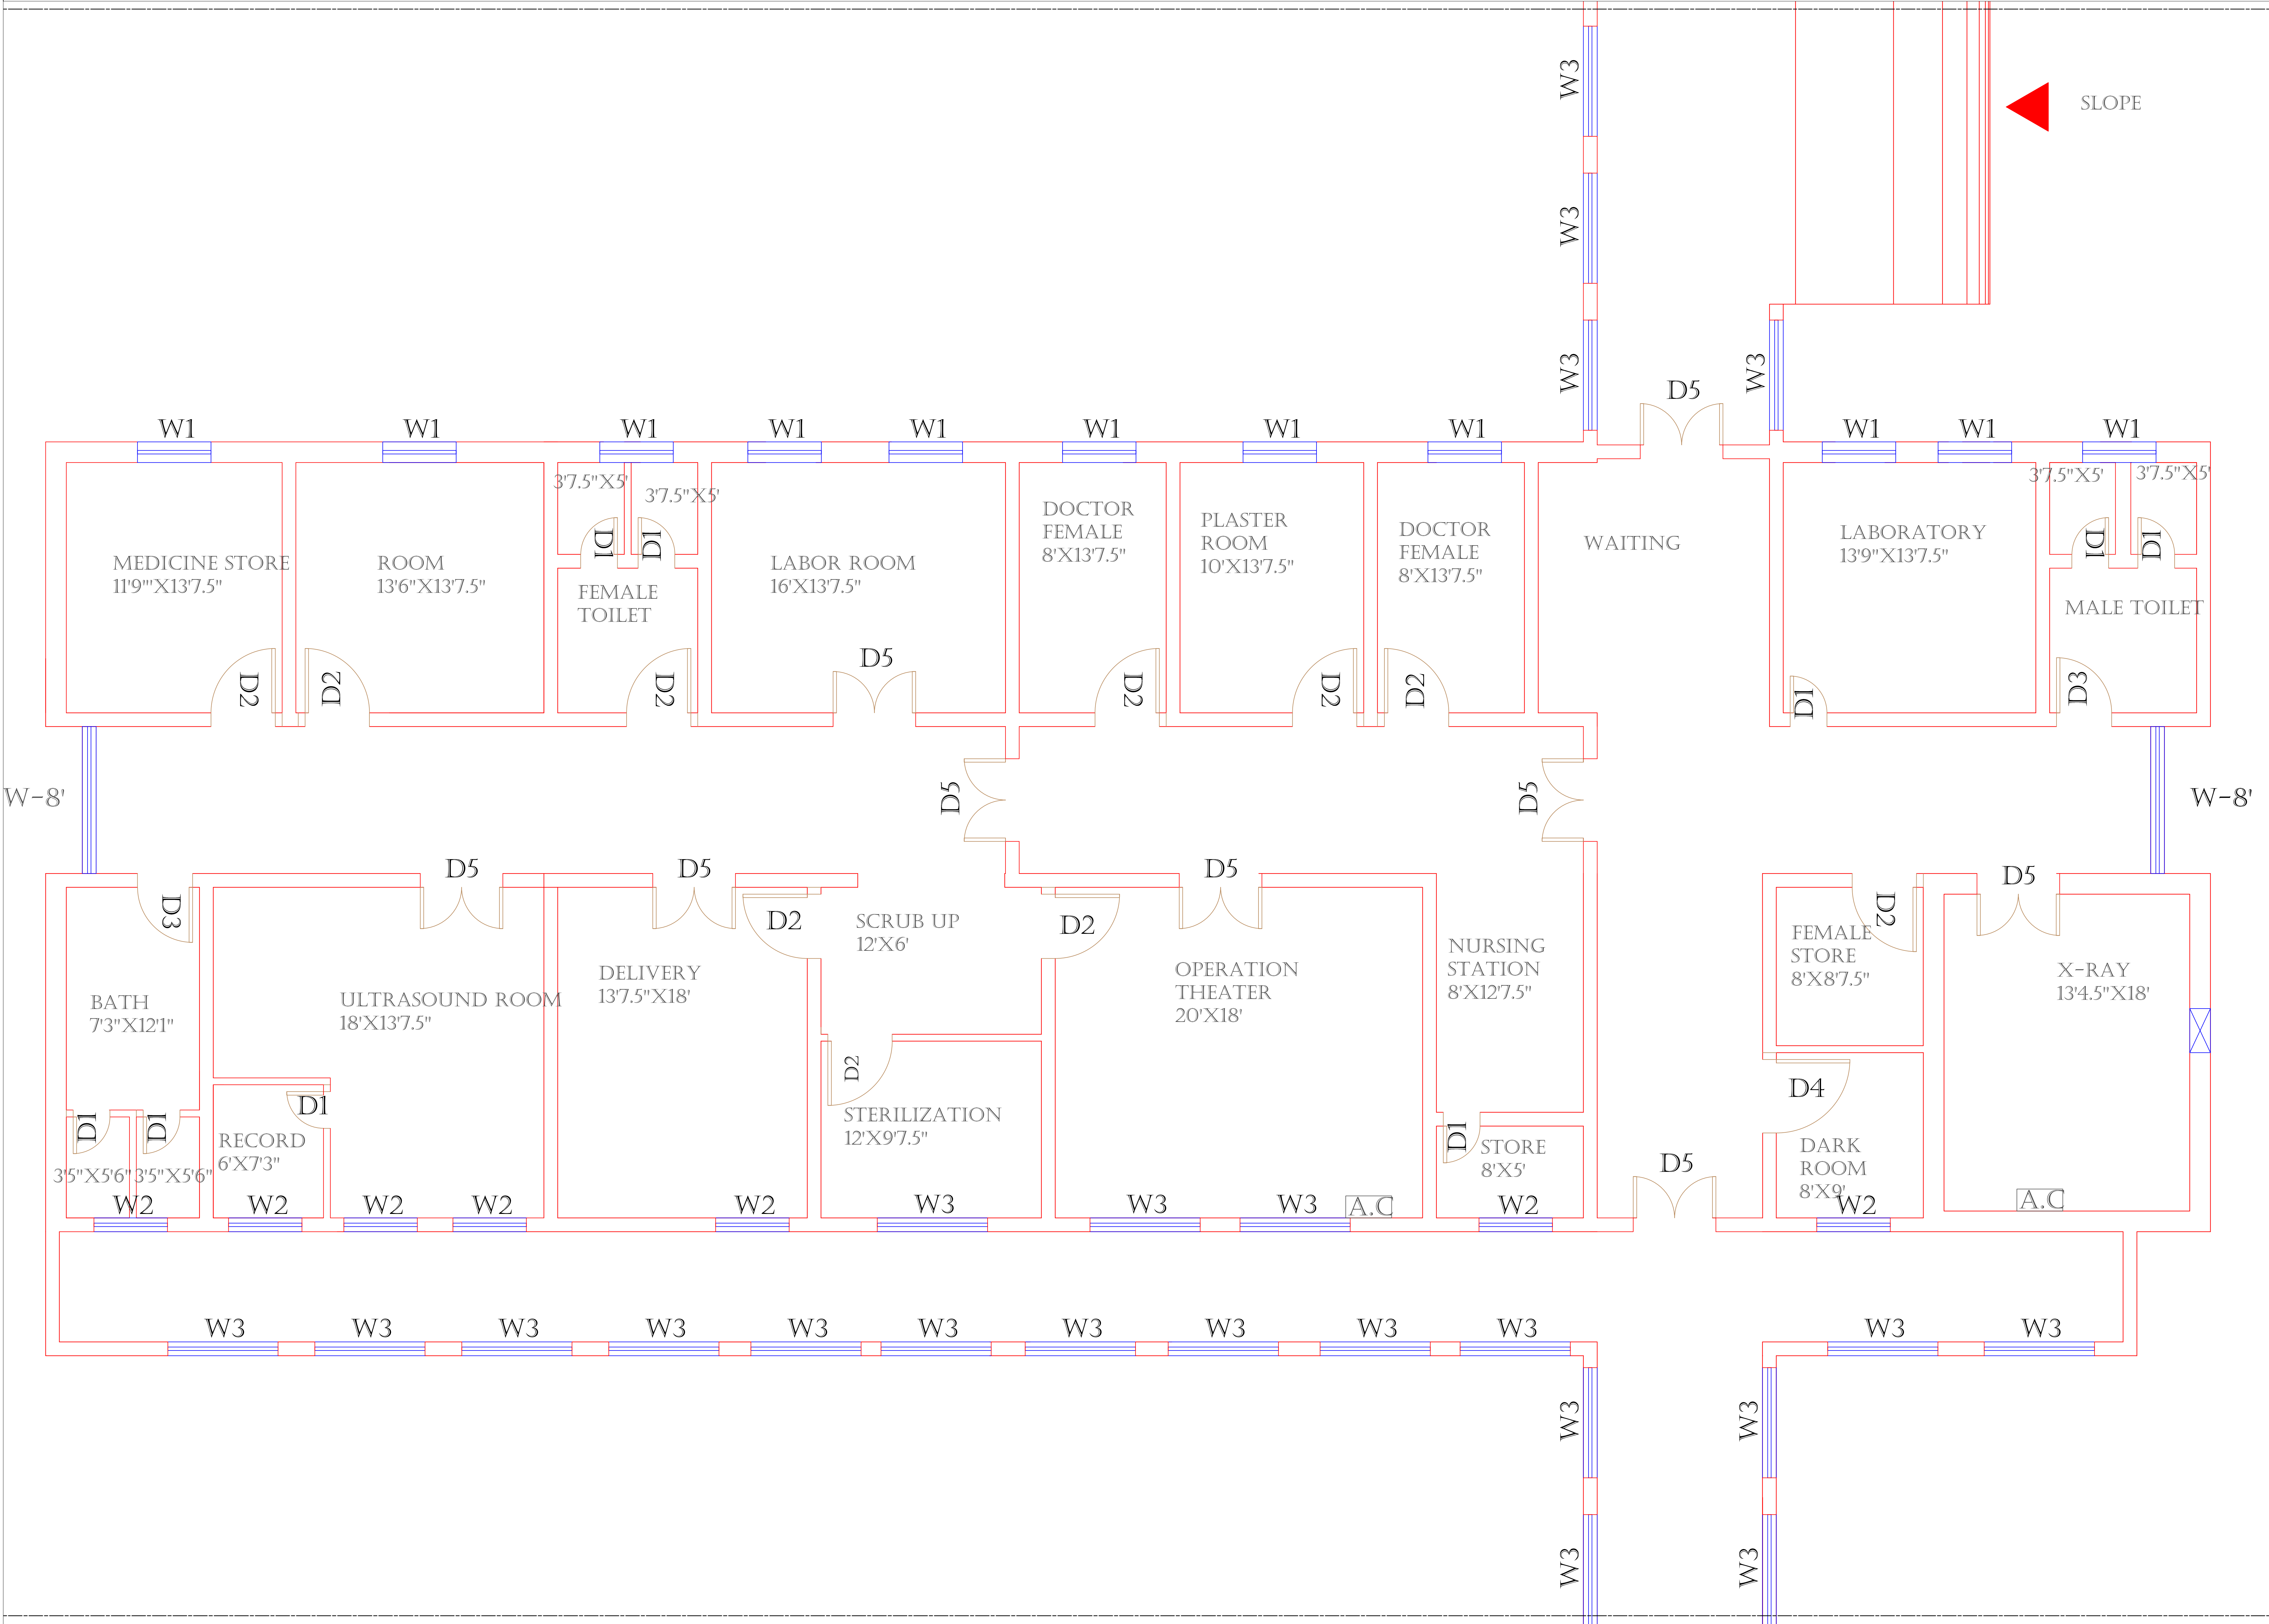

**Legends:**

RESIDENTIAL AREA	
ROAD	
WALL	
POWER LINE	
OHT	
TREE	
MANHOLE	
TUBE WELL	
LIGHT POLE	
LAWNS	
EARTHEN AREAS	
ASPHALTS ROADS	
TOUGH PAVERS	
P.C.C /PLINTH PROTECTION	
BOUNDARY WALL	
TAP	
HAND PUMP	
BRICK PAVERS	
AIR CONDITIONER	
TUBE LIGHT	
FAN	
ROOF LIGHT	
BULB	

AREA	
AREA WITHIN BOUNDARY WALL	287604.20 SFT
AREA OF CLINICAL BLOCK	26415.544 SFT
PLINTH AREA OF BLOCK	SFT

OPENING SCHEDULE OF DOORS AND WINDOWS					
DOORS	WIDTH	HEIGHT	WINDOWS	WIDTH	HEIGHT
D1	2'-0"	7'-0"	W1	3'-0"	5'-0"
D2	3'-6"	7'-0"	W2	4'-0"	4'-0"
D3	3'-0"	7'-0"	W3	6'-0"	6'-0"
D4	4'-0"	7'-0"	W4	8'-0"	12'-0"
D5	4'-6"	7'-0"	W5		
D6			W6		
D7			W7		
D8			V1	1'-6"	1'-6"
D9			V2		

Client:

GOVERNMENT OF THE PUNJAB  
PRIMARY & SECONDARY  
HEALTHCARE DEPARTMENT

Project:

**CAD MAPPING OF TEHSIL  
HEAD QUARTER HOSPITALS,  
PUNJAB**

Consultant:

**SKAFS CONSULTANT (Pvt.) Limited**  
ENGINEERING AND ENVIRONMENT CONSULTANT

Drawing Title:

**THQ TANDIYAWALA  
HOSPITAL CLINICAL BLOCK  
PART 3**

Authorized By: SKAFS	Reviewed By Co-Team Leader	Scale:
Prepared By: CAD TEAMS	Date: FEB, 2017	


Drawing No.

**SKAFS/TANDIYAWALA /11**



# CLINICAL BLOCK OF THQ HOSPITAL TANDIYAWALA

## GROUND FLOOR (PART 4)

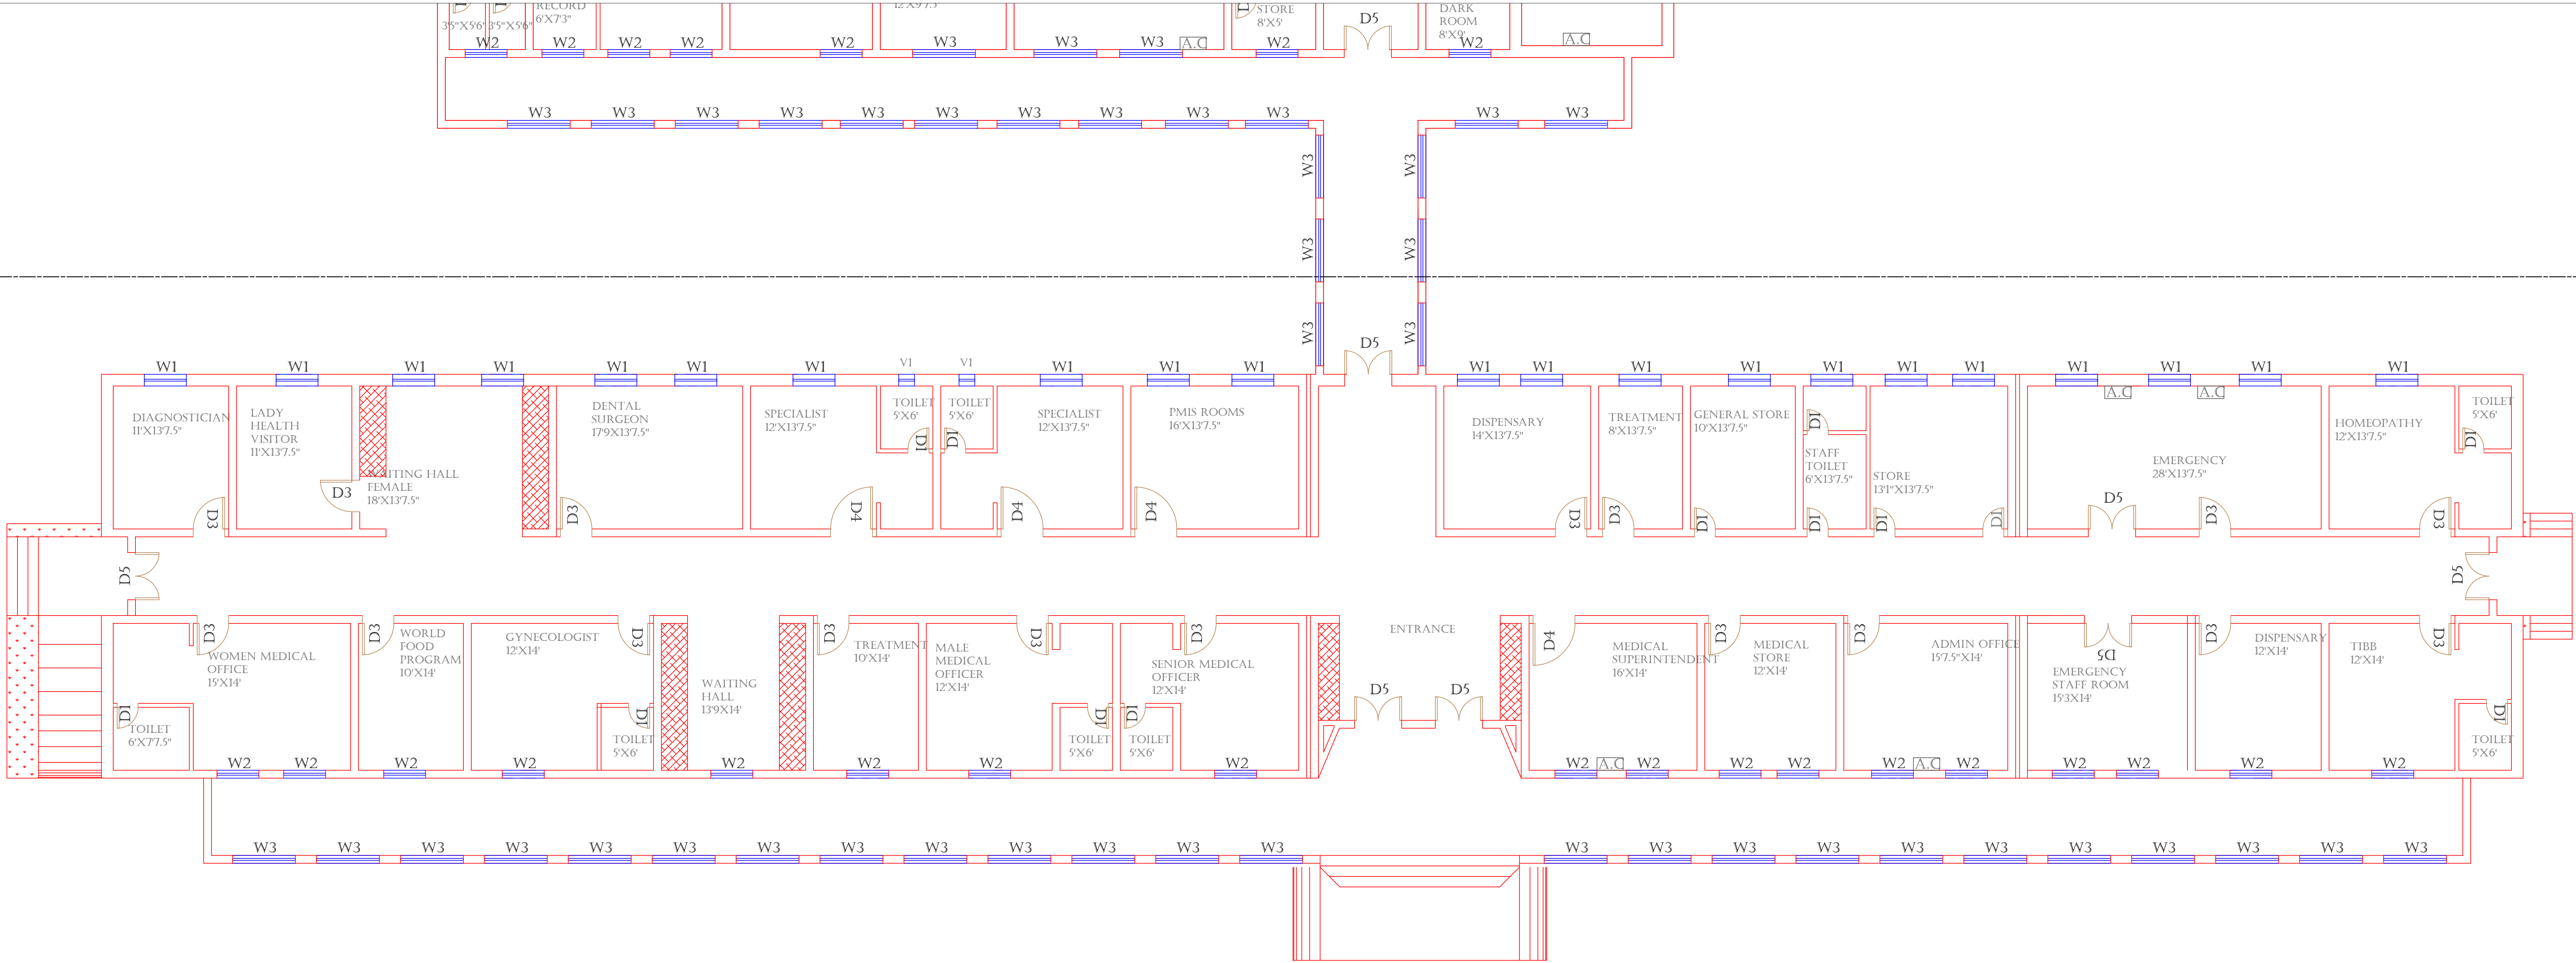

**Legends:**

RESIDENTIAL AREA	
ROAD	
WALL	
POWER LINE	
OHT	
TREE	
MANHOLE	
TUBE WELL	
LIGHT POLE	
LAWNS	
EARTHEN AREAS	
ASPHALTS ROADS	
TOUGH PAVERS	
P.C.C /PLINTH PROTECTION	
BOUNDARY WALL	
TAP	
HAND PUMP	
BRICK PAVERS	
AIR CONDITIONER	
TUBE LIGHT	
FAN	
ROOF LIGHT	
BULB	

AREA	
AREA WITHIN BOUNDARY WALL	287604.20 SFT
AREA OF CLINICAL BLOCK	26415.544 SFT
PLINTH AREA OF BLOCK	SFT

OPENING SCHEDULE OF DOORS AND WINDOWS					
DOORS	WIDTH	HEIGHT	WINDOWS	WIDTH	HEIGHT
D1	2'-0"	7'-0"	W1	3'-0"	5'-0"
D2	3'-6"	7'-0"	W2	4'-0"	4'-0"
D3	3'-0"	7'-0"	W3	6'-0"	6'-0"
D4	4'-0"	7'-0"	W4	8'-0"	12'-0"
D5	4'-6"	7'-0"	W5		
D6			W6		
D7			W7		
D8			V1	1'-6"	1'-6"
D9			V2		

Client:



**GOVERNMENT OF THE PUNJAB**  
**PRIMARY & SECONDARY**  
**HEALTHCARE DEPARTMENT**

Project:

**CAD MAPPING OF TEHSIL**  
**HEAD QUARTER HOSPITALS,**  
**PUNJAB**

Consultant:



**SKAFS CONSULTANT (Pvt.) Limited**  
ENGINEERING AND ENVIRONMENT CONSULTANT

Drawing Title:

**THQ TANDIYAWALA**  
**HOSPITAL CLINICAL BLOCK**  
**PART 4**

Authorized By: SKAFS	Reviewed By Co-Team Leader	Scale:
-------------------------	-------------------------------	--------


Prepared By: CAD TEAMS	Date: FEB, 2017	
---------------------------	--------------------	--

Drawing No. **SKAFS/TANDIYAWALA /12**



# ELECTRICAL LAYOUT PLAN OF THQ HOSPITAL TANDIYAWALA

## GROUND FLOOR

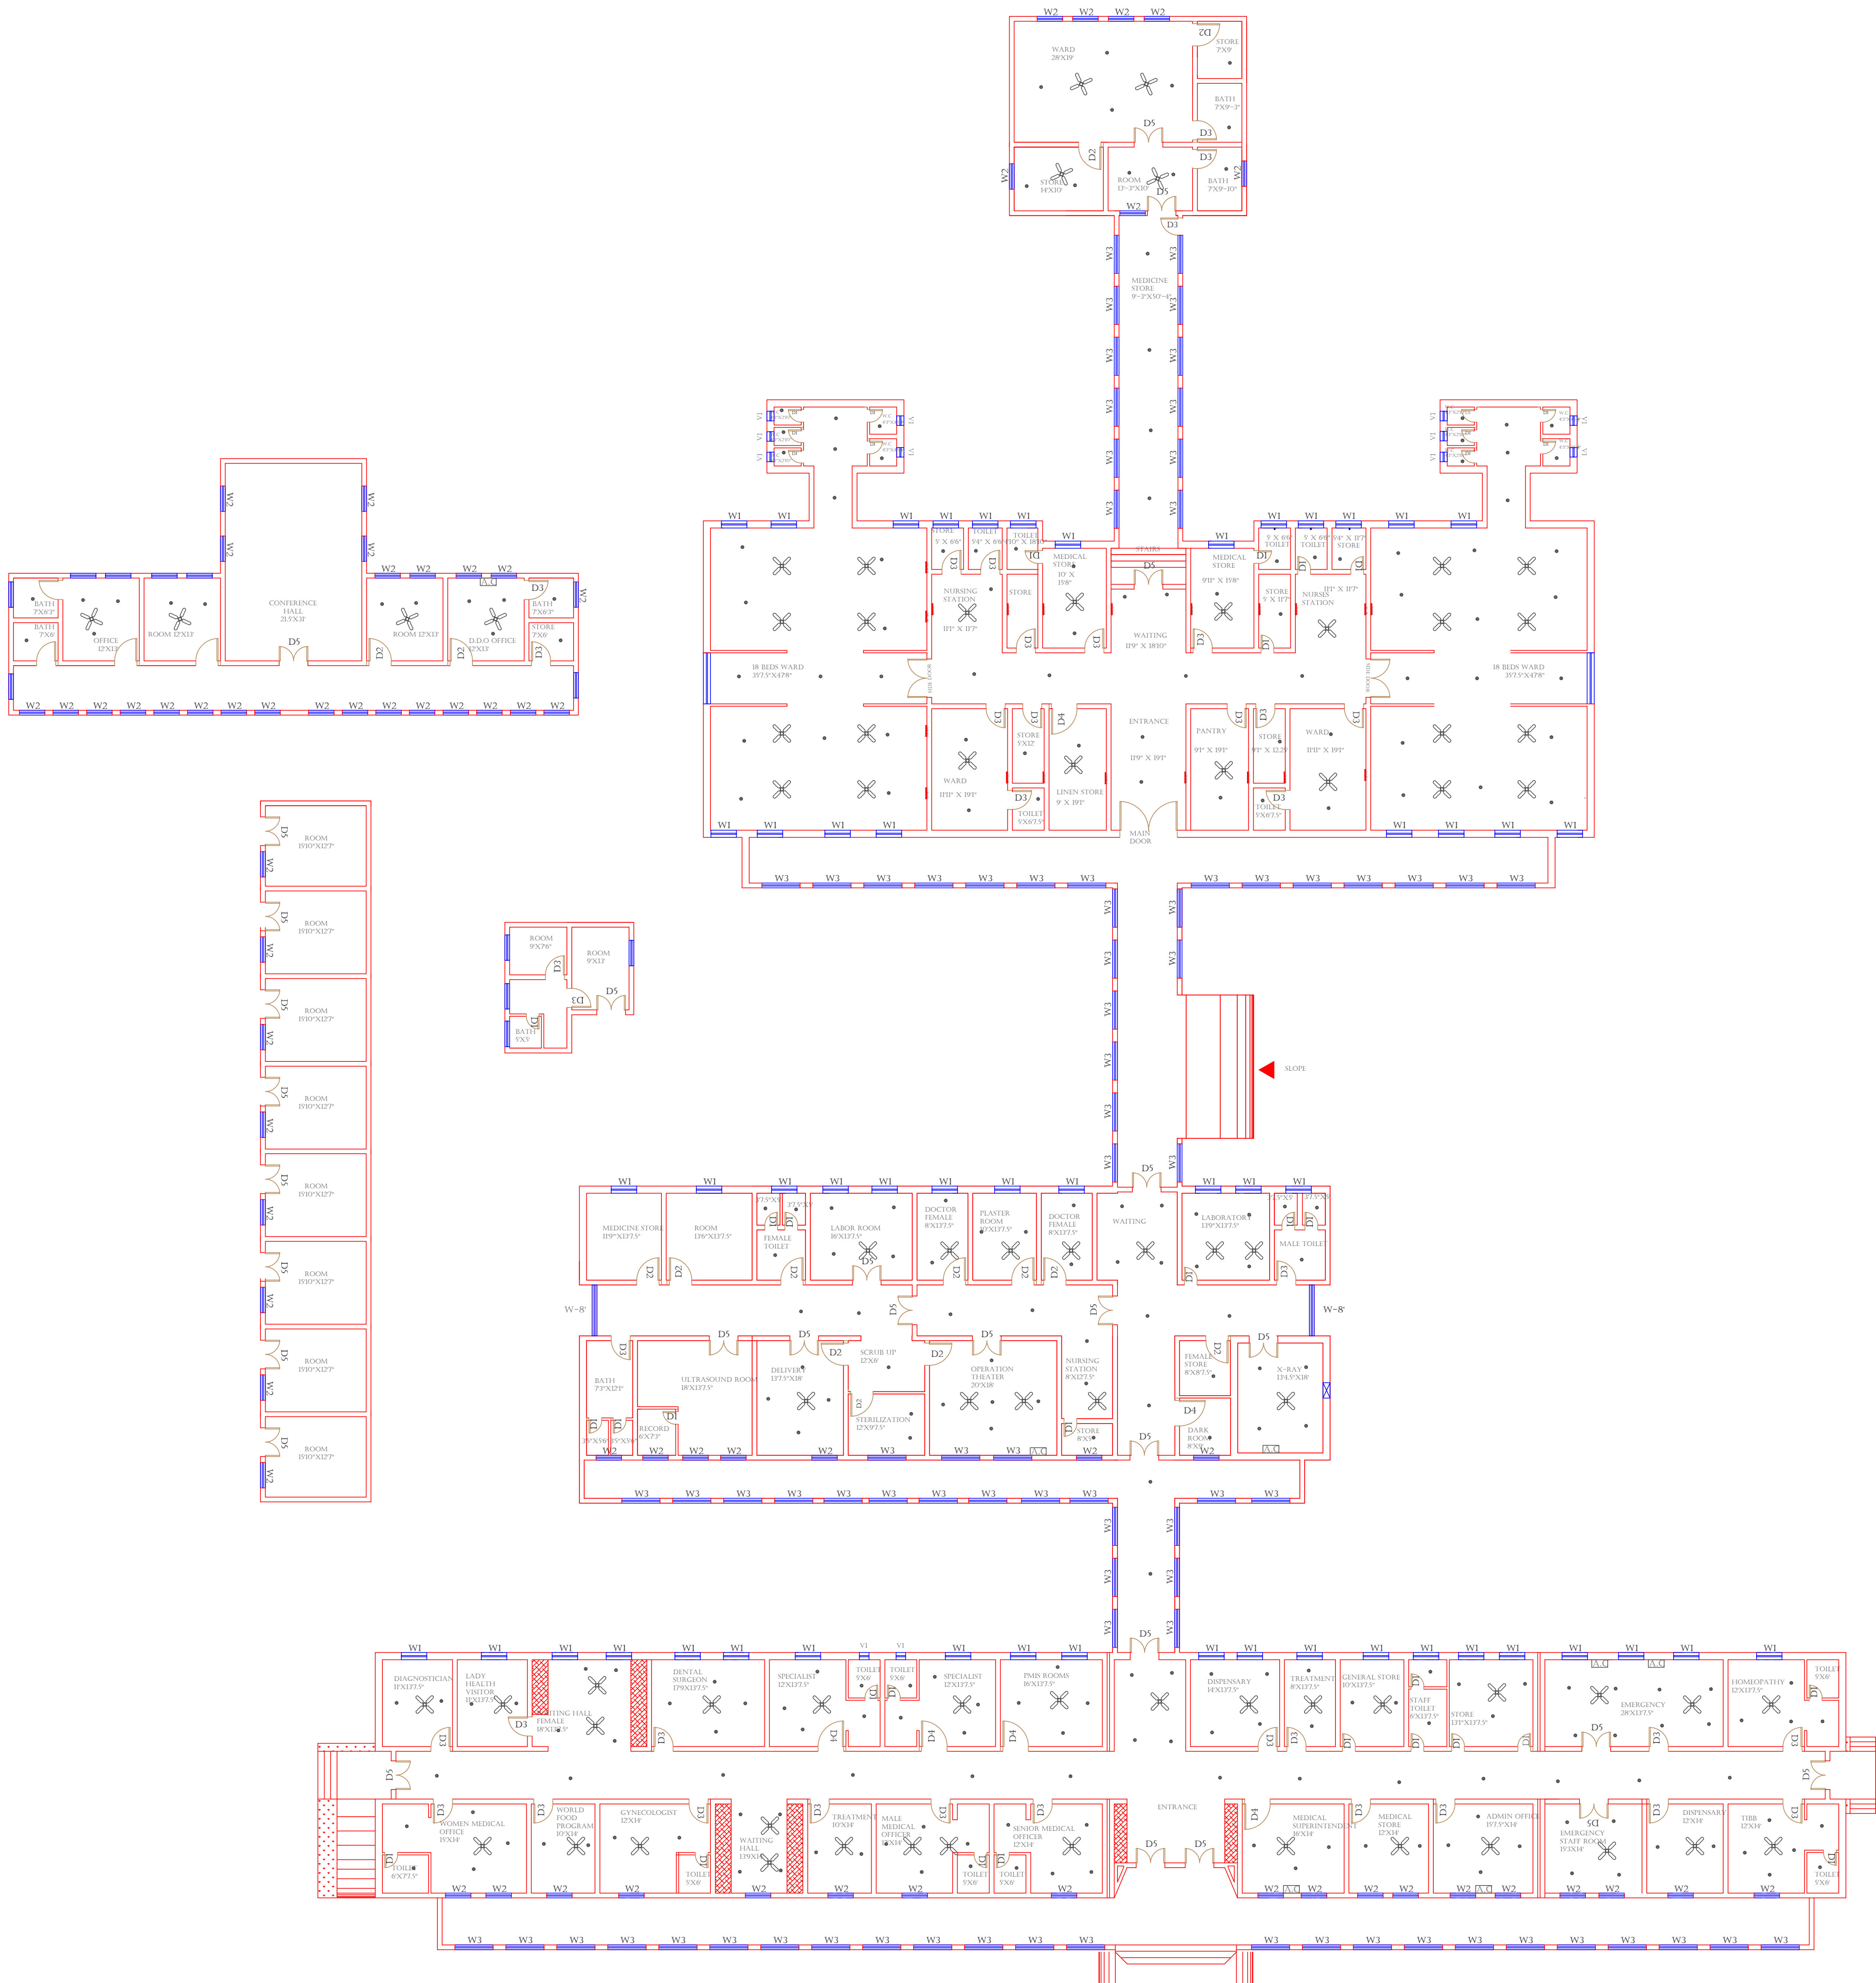

**Legends:**

RESIDENTIAL AREA	
ROAD	
WALL	
POWER LINE	
OHT	
TREE	
MANHOLE	
TUBE WELL	
LIGHT POLE	
LAWNS	
EARTHEN AREAS	
ASPHALTS ROADS	
TOUGH PAVERS	
P.C.C /PLINTH PROTECTION	
BOUNDARY WALL	
TAP	
HAND PUMP	
BRICK PAVERS	
AIR CONDITIONER	
TUBE LIGHT	
FAN	
ROOF LIGHT	
BULB	

AREA	
AREA WITHIN BOUNDARY WALL	287604.20 SFT
AREA OF CLINICAL BLOCK	26415.544 SFT
PLINTH AREA OF BLOCK	SFT

OPENING SCHEDULE OF DOORS AND WINDOWS					
DOORS	WIDTH	HEIGHT	WINDOWS	WIDTH	HEIGHT
D1	2'-0"	7'-0"	W1	3'-0"	5'-0"
D2	3'-6"	7'-0"	W2	4'-0"	4'-0"
D3	3'-0"	7'-0"	W3	6'-0"	6'-0"
D4	4'-0"	7'-0"	W4	8'-0"	12'-0"
D5	4'-6"	7'-0"	W5		
D6			W6		
D7			W7		
D8			V1	1'-6"	1'-6"
D9			V2		

Client:

**GOVERNMENT OF THE PUNJAB**  
**PRIMARY & SECONDARY**  
**HEALTHCARE DEPARTMENT**

Project:

**CAD MAPPING OF TEHSIL**  
**HEAD QUARTER HOSPITALS,**  
**PUNJAB**

Consultant:

**SKAFS CONSULTANT (Pvt.) Limited**  
ENGINEERING AND ENVIRONMENT CONSULTANT

Drawing Title:

**THQ TANDIYAWALA**  
**ELECTRICAL LAYOUT**  
**GROUND FLOOR**

Authorized By: SKAFS	Reviewed By Co-Team Leader	Scale:
Prepared By: CAD TEAMS	Date: FEB, 2017	
Drawing No.		SKAFS/TANDIYAWALA /13