

MASTER PLAN OF THQ HOSPITAL CHOA SAIDEN SHAH

PART 1

PART 2

PART 3

PART 4

Legends:

Residential Area	
Road	
Wall	
Power Line	
OHT	
Tree	
Man Hole	
Tube Well	
Light Pole	
Lawns	
Earthen Areas	
Asphalts Roads	
Tough Pavers	
P.C.C / Plinth Protection	
Boundary Wall	
Brick Pavers / Soling	
Drain	
Tap	
Hand Pump	
Air Conditioner	
Tube Light	
Fan	
Roof Light	
Bulb	

AREA					
AREA WITHIN BOUNDARY WALL		301355.095 Sft			
AREA OF CLINICAL BLOCK		22389.3331 Sft			
PLINTH AREA OF BLOCK		22389.3331 Sft			


OPENING SCHEDULE OF DOORS AND WINDOWS					
DOORS	WIDTH	HEIGHT	WINDOWS	WIDTH	HEIGHT
D1	2'-0"	7'-0"	W1	3'-0"	5'-0"
D2	2'-6"	7'-0"	W2	4'-0"	4'-0"
D3	3'-0"	7'-0"	W3	6'-0"	6'-0"
D4	3'-6"	7'-0"	W4	8'-0"	8'-0"
D5	4'-0"	7'-0"	W5	5'-0"	5'-0"
D6	4'-6"	7'-0"	W6		
D7	5'-0"	7'-0"	W7		
D8	6'-0"	7'-0"	V1	2'-0"	2'-0"
D9	7'-0"	7'-0"	V2		

Project:
**CAD MAPPING OF TEHSIL
HEAD QUARTER HOSPITALS,
PUNJAB**

Client: GOVERNMENT OF THE PUNJAB PRIMARY & SECONDARY HEALTHCARE DEPARTMENT	Consultant: SKAFS CONSULTANT (Pvt.) Limited ENGINEERING AND ENVIRONMENT CONSULTANT
---	--



Drawing Title:
**THQ CHOA SAIDEN SHAH
HOSPITAL MASTER PLAN**

Drawing No.
SKAFS/CHOA SAIDEN SHAH/03

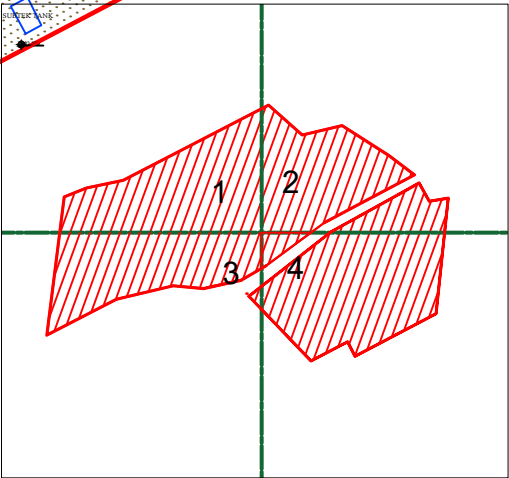

MASTER PLAN OF THQ HOSPITAL CHOA SAIDEN SHAH

PART 1

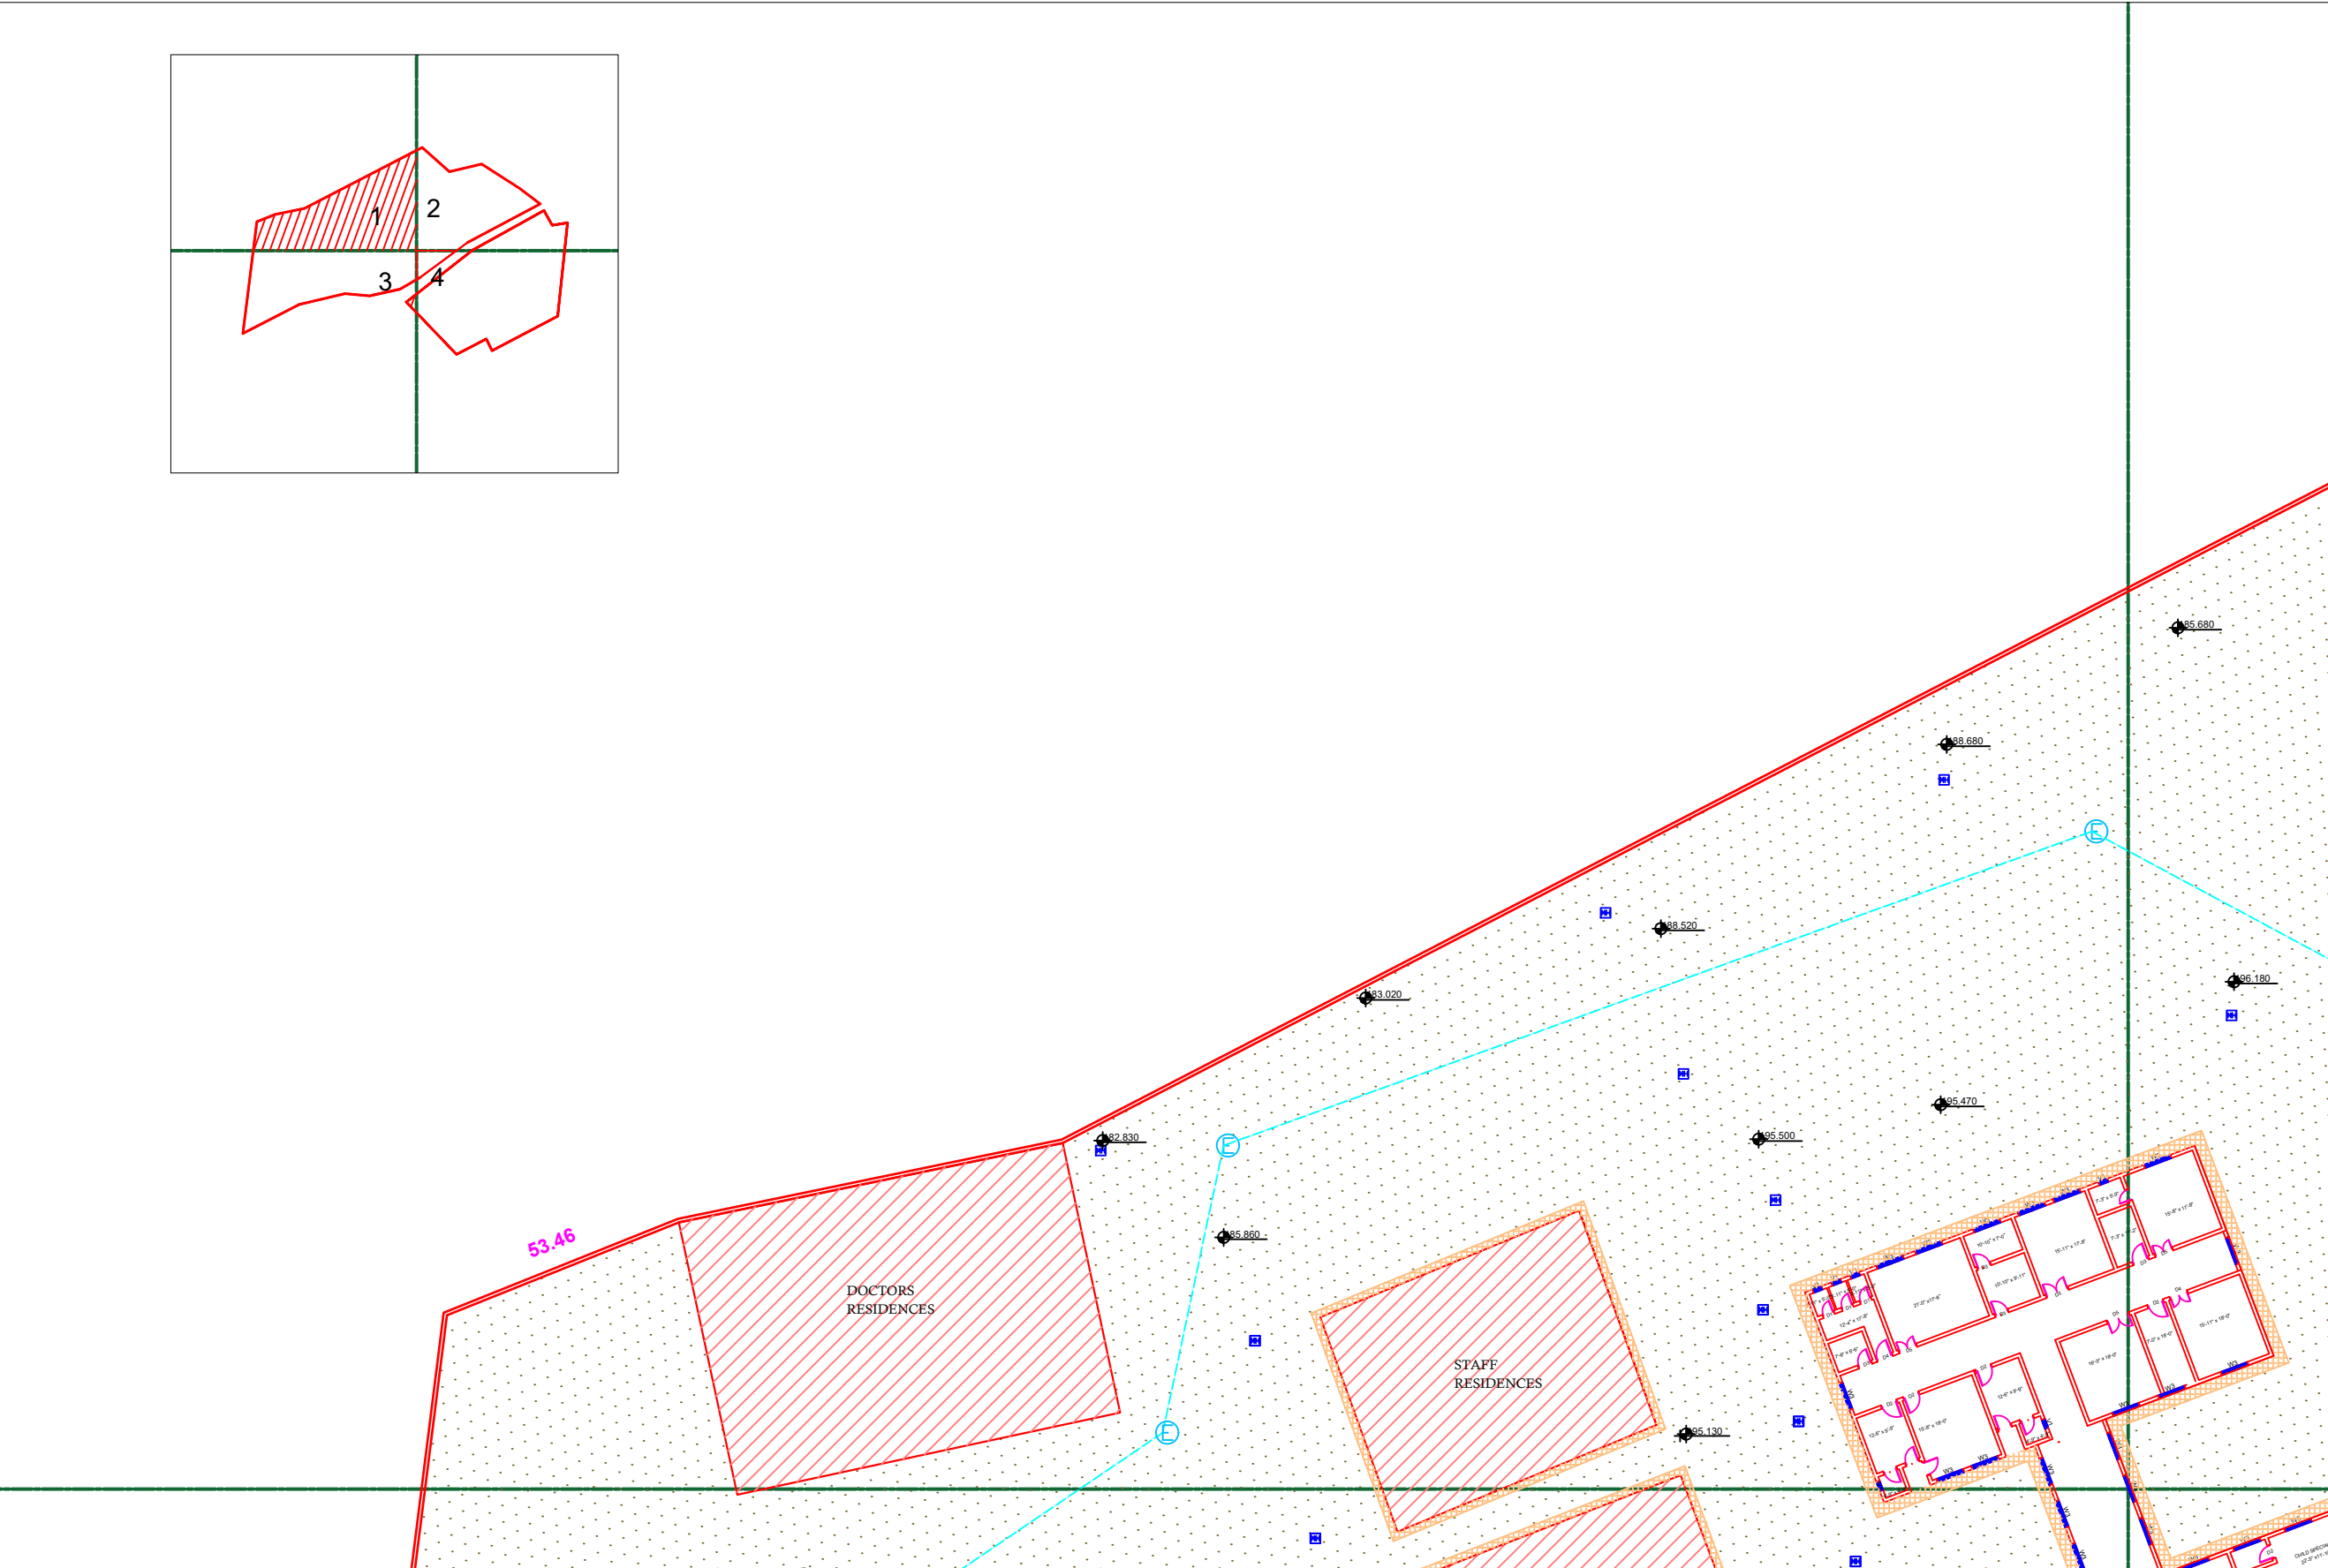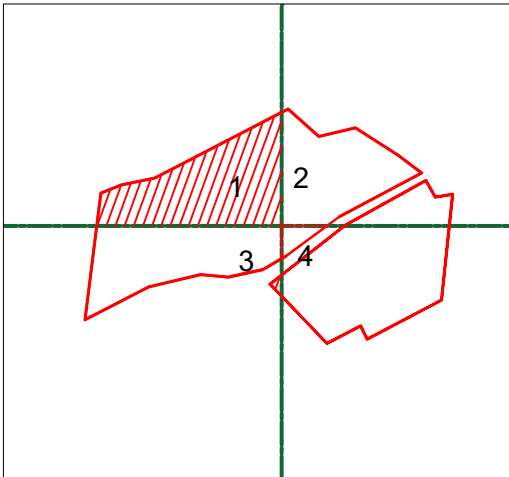

Legends:

Residential Area	
Road	
Wall	
Power Line	
OHT	
Tree	
Man Hole	
Tube Well	
Light Pole	
Lawns	
Earthen Areas	
Asphalts Roads	
Tough Pavers	
P.C.C / Plinth Protection	
Boundary Wall	
Brick Pavers / Soling	
Drain	
Tap	
Hand Pump	
Air Conditioner	
Tube Light	
Fan	
Roof Light	
Bulb	

AREA

AREA WITHIN BOUNDARY WALL	301355.095 Sft
AREA OF CLINICAL BLOCK	22389.3331 Sft
PLINTH AREA OF BLOCK	22389.3331 Sft

OPENING SCHEDULE OF DOORS AND WINDOWS

DOORS	WIDTH	HEIGHT	WINDOWS	WIDTH	HEIGHT
D1	2'-0"	7'-0"	W1	3'-0"	5'-0"
D2	2'-6"	7'-0"	W2	4'-0"	4'-0"
D3	3'-0"	7'-0"	W3	6'-0"	6'-0"
D4	3'-6"	7'-0"	W4	8'-0"	8'-0"
D5	4'-0"	7'-0"	W5	5'-0"	5'-0"
D6	4'-6"	7'-0"	W6		
D7	5'-0"	7'-0"	W7		
D8	6'-0"	7'-0"	V1	2'-0"	2'-0"
D9	7'-0"	7'-0"	V2		

Project:
CAD MAPPING OF TEHSIL HEAD QUARTER HOSPITALS, PUNJAB



Client: GOVERNMENT OF THE PUNJAB PRIMARY & SECONDARY HEALTHCARE DEPARTMENT	Consultant: SKAFS CONSULTANT (Pvt.) Limited ENGINEERING AND ENVIRONMENT CONSULTANT
--	---

Drawing Title:
THQ CHOA SAIDEN SHAH HOSPITAL MASTER PLAN PART 1

Drawing No.
SKAFS/CHOA SAIDEN SHAH/04

MASTER PLAN OF THQ HOSPITAL CHOA SAIDEN SHAH

PART 2

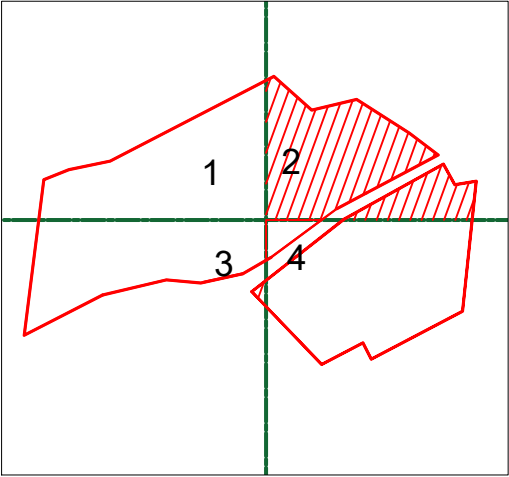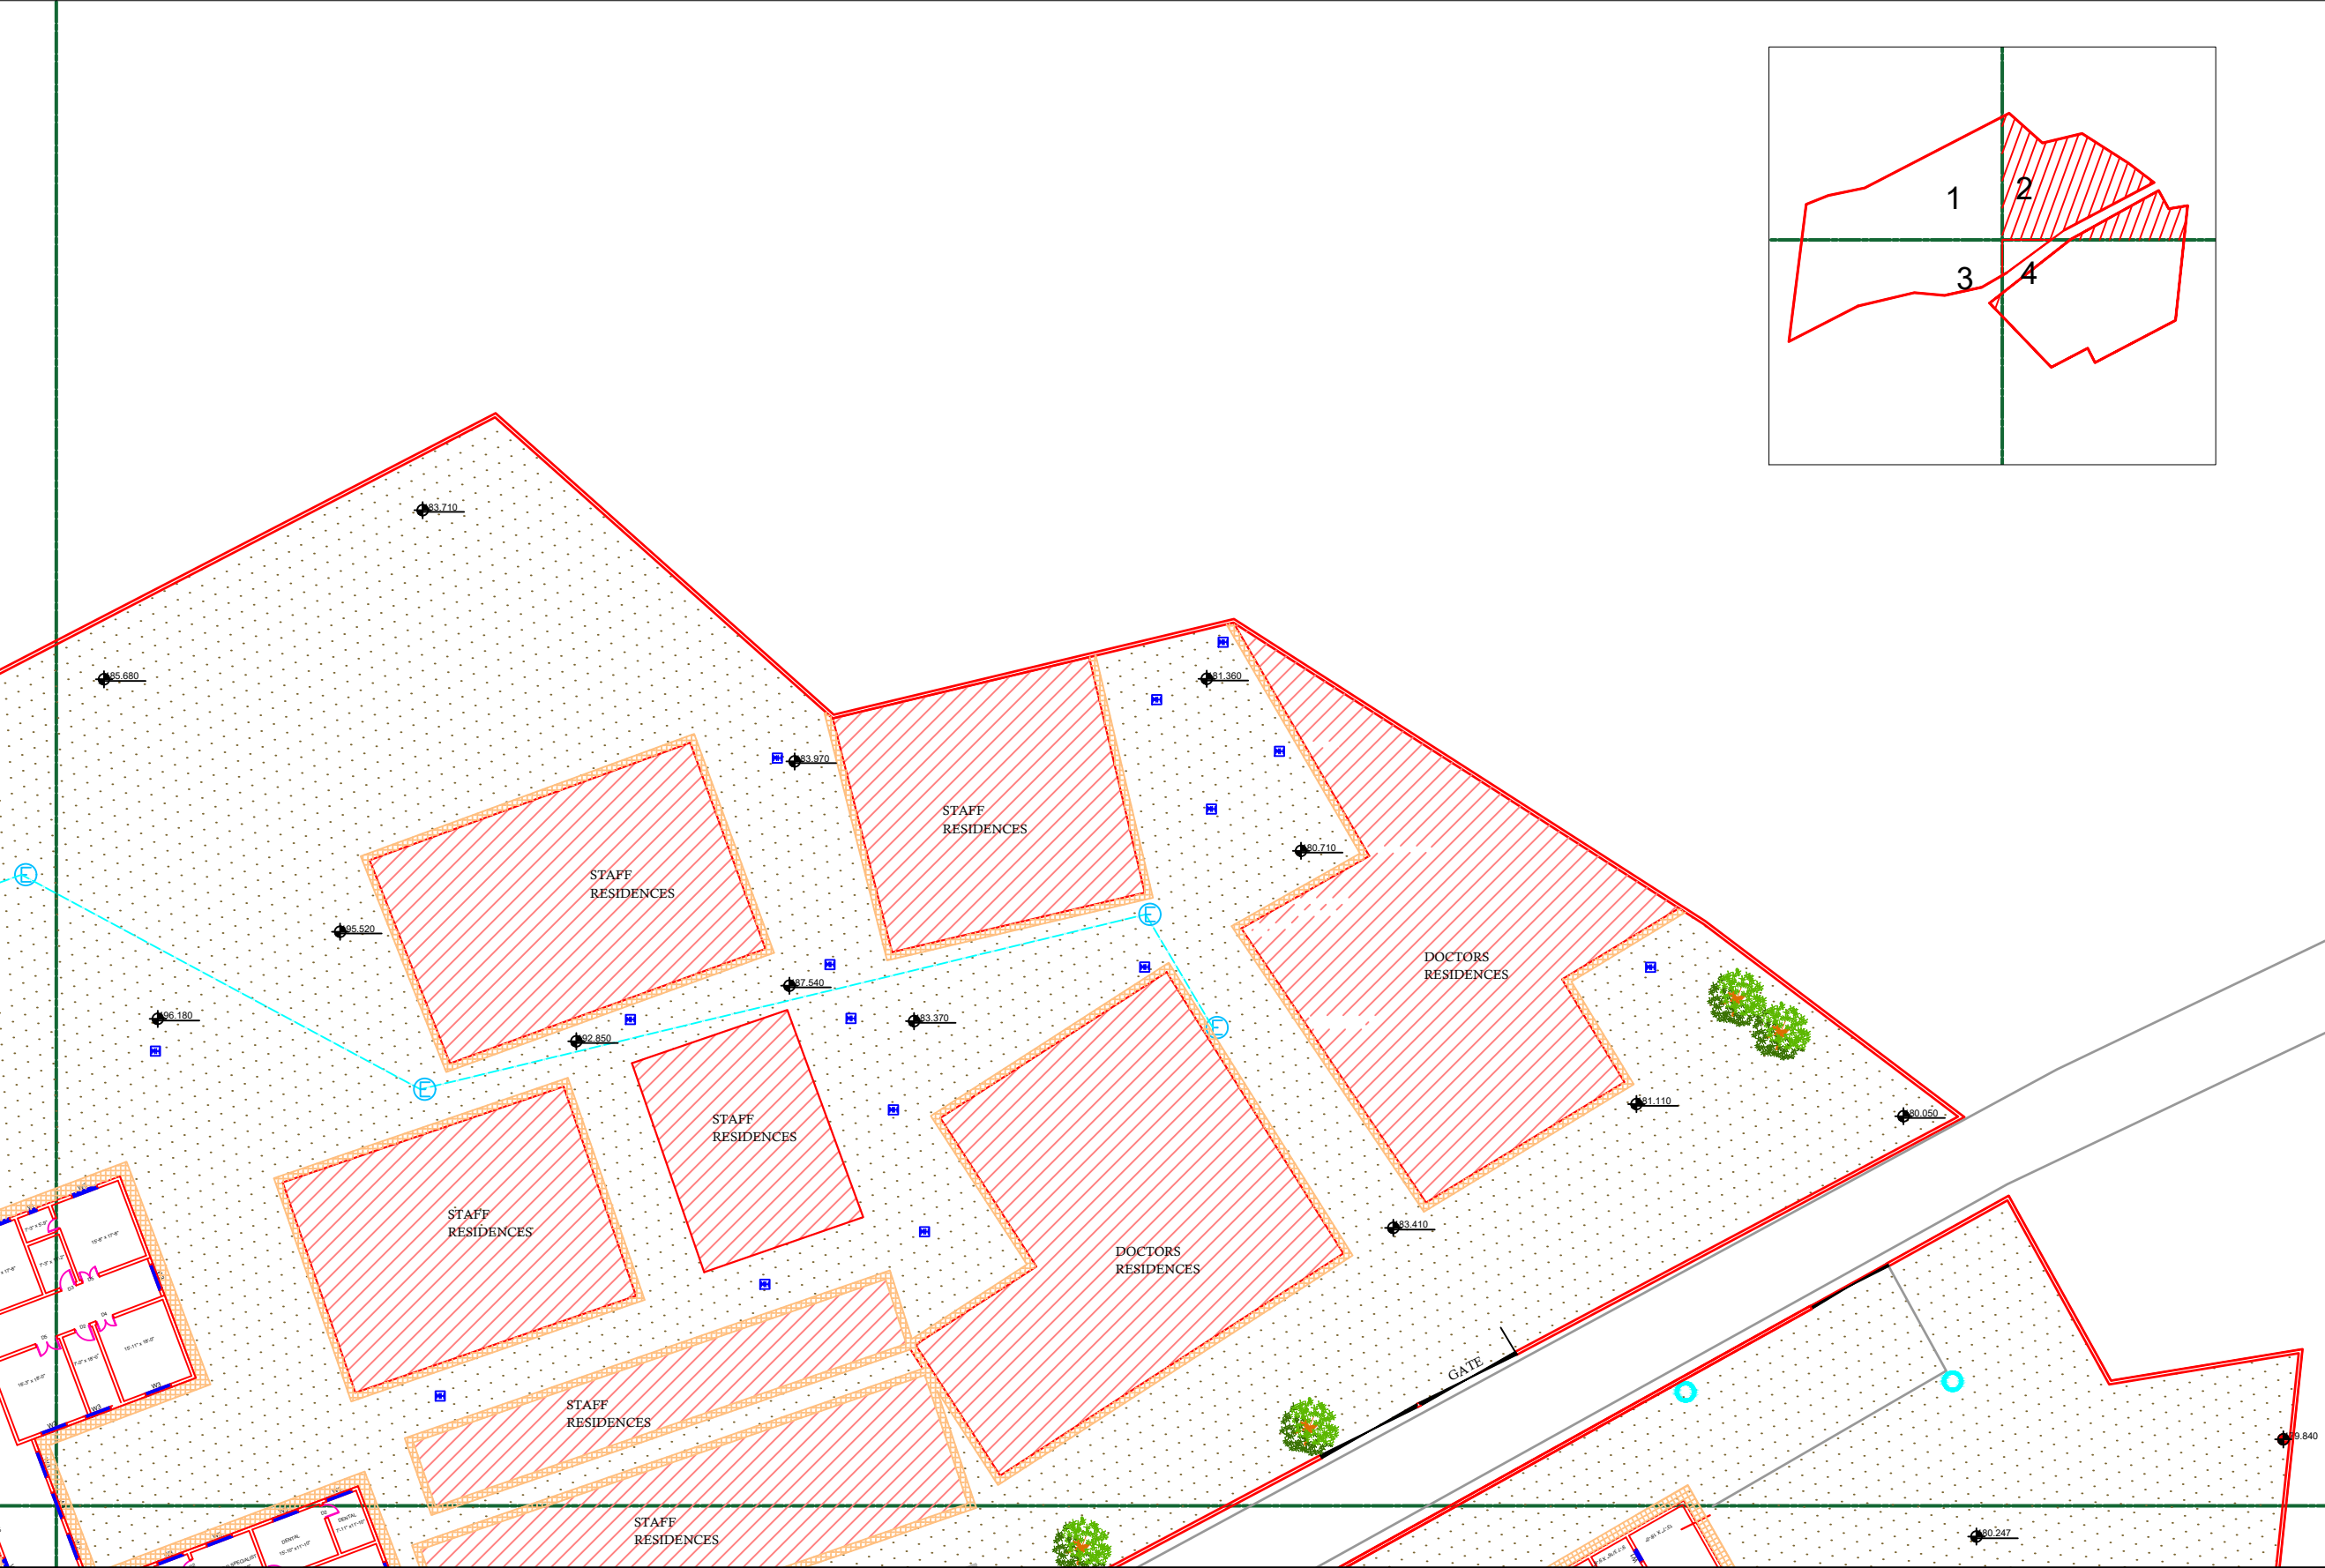

Legends:

Residential Area	
Road	
Wall	
Power Line	
OHT	
Tree	
Man Hole	
Tube Well	
Light Pole	
Lawns	
Earthen Areas	
Asphalts Roads	
Tough Pavers	
P.C.C / Plinth Protection	
Boundary Wall	
Brick Pavers / Soling	
Drain	
Tap	
Hand Pump	
Air Conditioner	
Tube Light	
Fan	
Roof Light	
Bulb	

AREA	
AREA WITHIN BOUNDARY WALL	301355.095 Sft
AREA OF CLINICAL BLOCK	22389.3331 Sft
PLINTH AREA OF BLOCK	22389.3331 Sft

OPENING SCHEDULE OF DOORS AND WINDOWS					
DOORS	WIDTH	HEIGHT	WINDOWS	WIDTH	HEIGHT
D1	2'-0"	7'-0"	W1	3'-0"	5'-0"
D2	2'-6"	7'-0"	W2	4'-0"	4'-0"
D3	3'-0"	7'-0"	W3	6'-0"	6'-0"
D4	3'-6"	7'-0"	W4	8'-0"	8'-0"
D5	4'-0"	7'-0"	W5	5'-0"	5'-0"
D6	4'-6"	7'-0"	W6		
D7	5'-0"	7'-0"	W7		
D8	6'-0"	7'-0"	V1	2'-0"	2'-0"
D9	7'-0"	7'-0"	V2		


Project:
**CAD MAPPING OF TEHSIL
HEAD QUARTER HOSPITALS,
PUNJAB**

Client: GOVERNMENT OF THE PUNJAB PRIMARY & SECONDARY HEALTHCARE DEPARTMENT	Consultant: SKAFS CONSULTANT (Pvt.) Limited ENGINEERING AND ENVIRONMENT CONSULTANT
---	--

Drawing Title:
**THQ CHOA SAIDEN SHAH
HOSPITAL MASTER PLAN PART 2**

Drawing No.
SKAFS/CHOA SAIDEN SHAH/05

A diagram illustrating a red polygon divided into four regions by a horizontal green line and a vertical green line. The regions are labeled 1, 2, 3, and 4. Region 3 is shaded with diagonal lines.

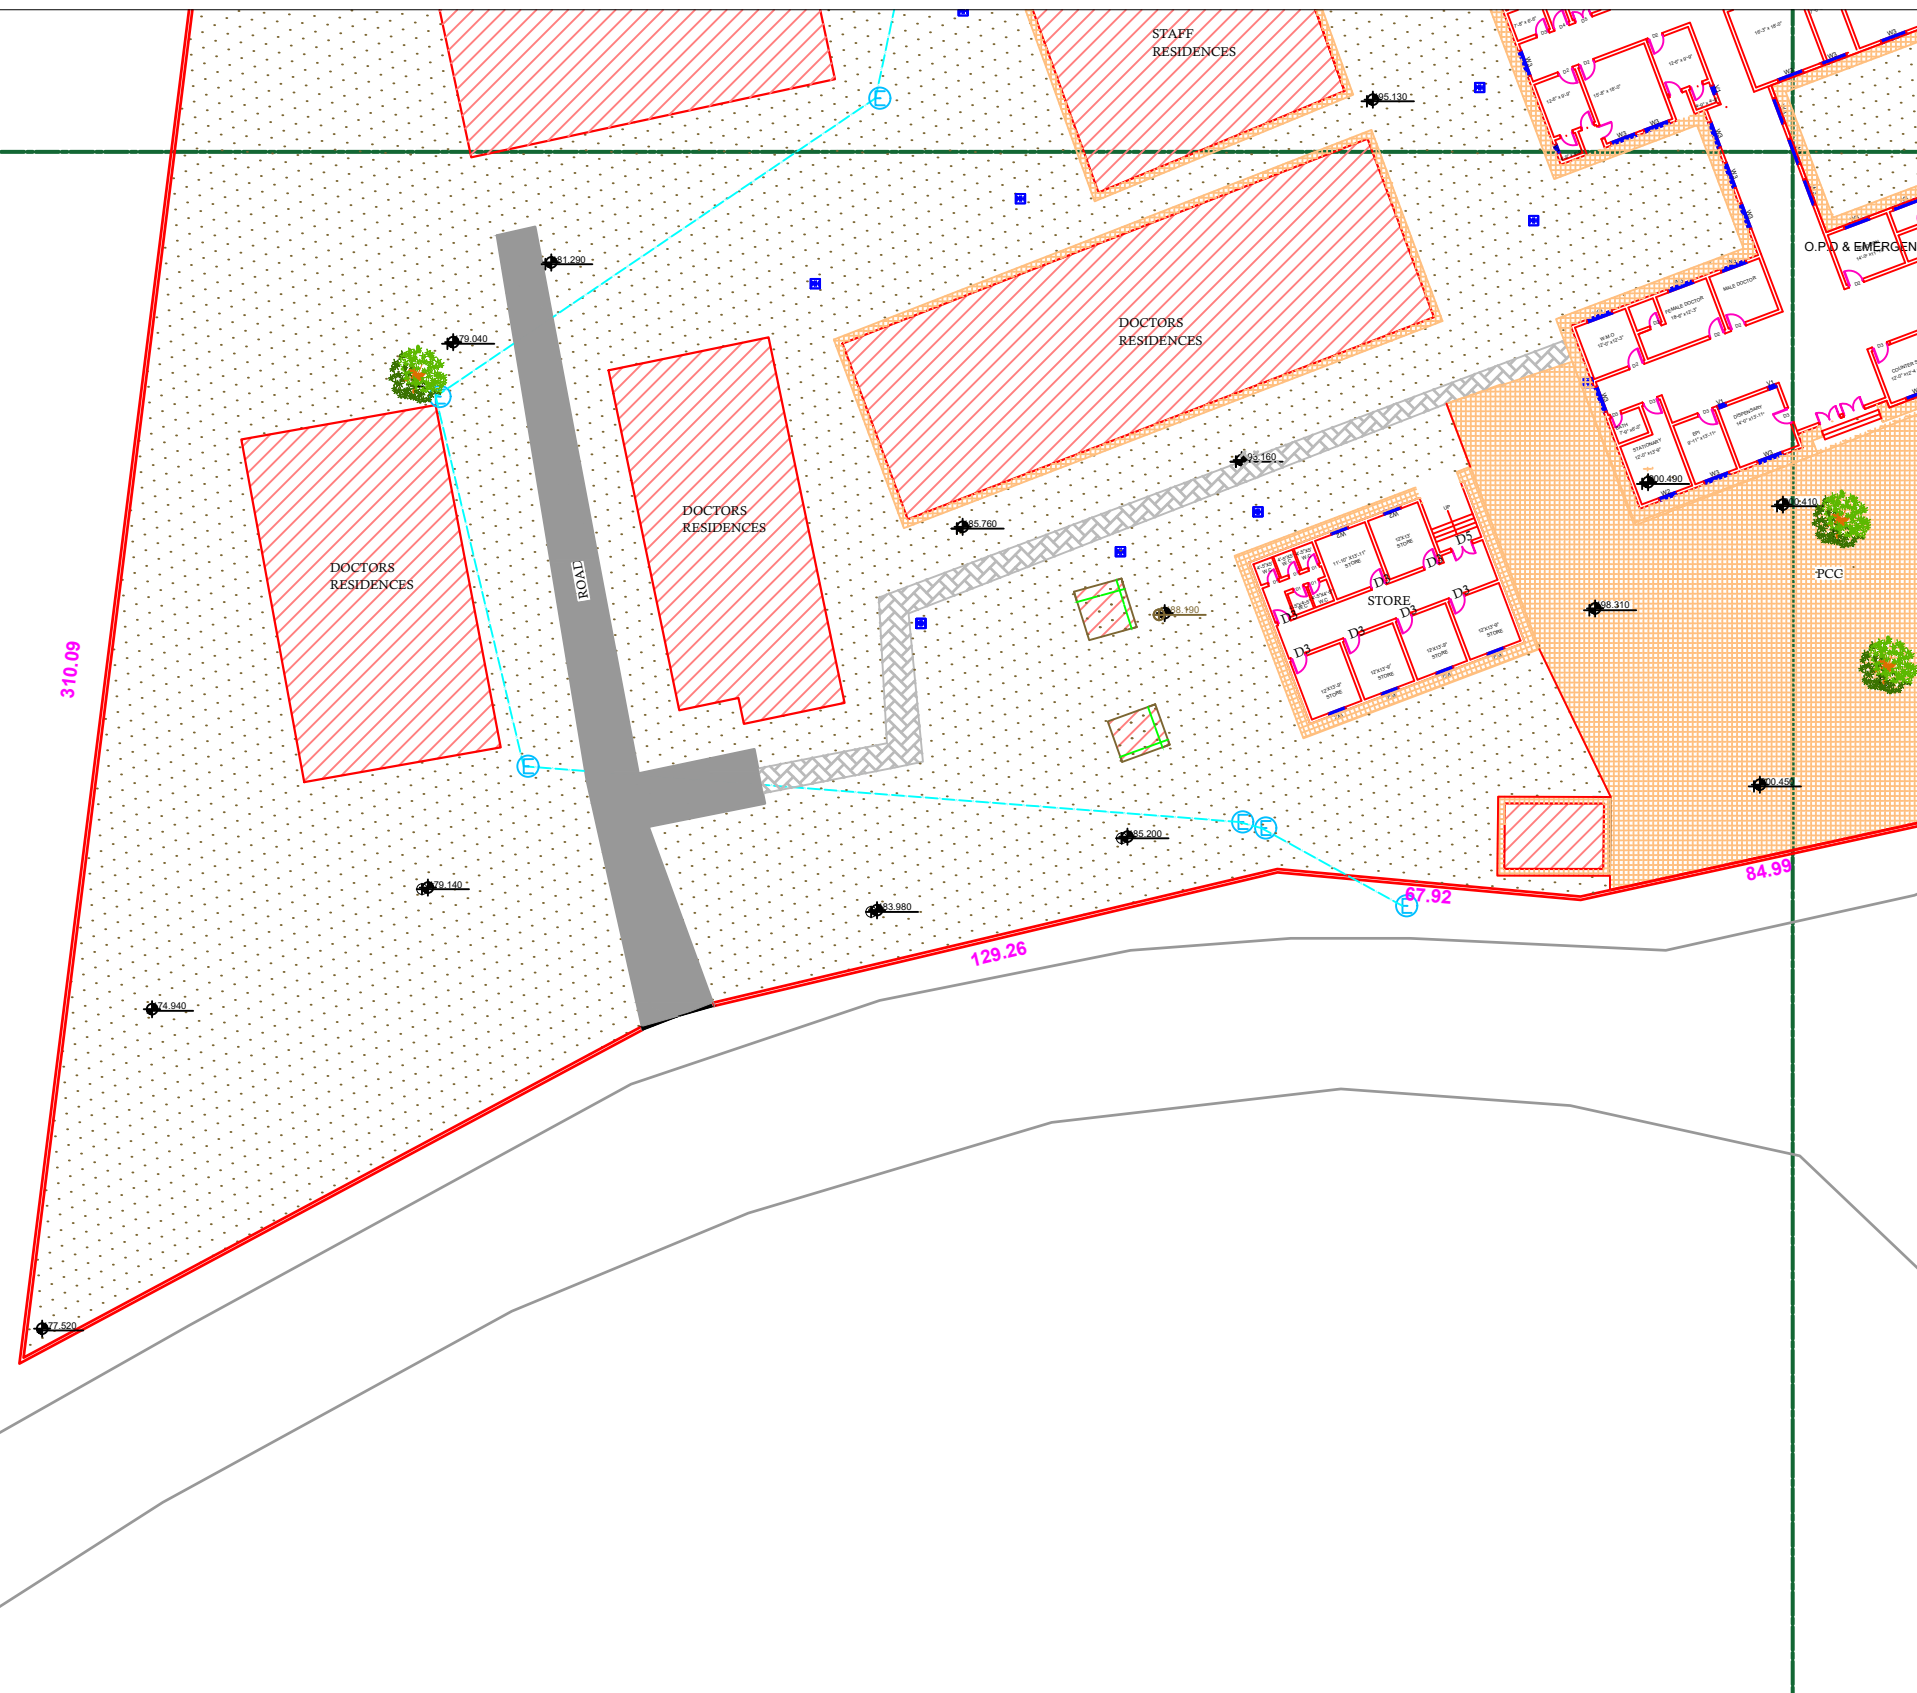

Residential Area	
Road	
Wall	
Power Line	
OHT	
Tree	
Man Hole	
Tube Well	
Light Pole	
Lawns	
Earthen Areas	
Asphalts Roads	
Tough Pavers	
P.C.C / Plinth Protection	
Boundary Wall	
Brick Pavers / Soling	
Drain	
Tap	
Hand Pump	
Air Conditioner	AC
Tube Light	
Fan	
Roof Light	
Bulb	

AREA	
AREA WITHIN BOUNDARY WALL	301355.095 Sft
AREA OF CLINICAL BLOCK	22389.3331 Sft
PLINTH AREA OF BLOCK	22389.3331 Sft

OPENING SCHEDULE OF DOORS AND WINDOWS					
DOORS	WIDTH	HEIGHT	WINDOWS	WIDTH	HEIGHT
D1	2'-0"	7'-0"	W1	3'-0"	5'-0"
D2	2'-6"	7'-0"	W2	4'-0"	4'-0"
D3	3'-0"	7'-0"	W3	6'-0"	6'-0"
D4	3'-6"	7'-0"	W4	8'-0"	8'-0"
D5	4'-0"	7'-0"	W5	5'-0"	5'-0"
D6	4'-6"	7'-0"	W6		
D7	5'-0"	7'-0"	W7		
D8	6'-0"	7'-0"	V1	2'-0"	2'-0"
D9	7'-0"	7'-0"	V2		

Project: **CAD MAPPING OF TEHSIL
HEAD QUARTER HOSPITALS,
PUNJAB**


Client:  GOVERNMENT OF THE PUNJAB PRIMARY & SECONDARY HEALTHCARE DEPARTMENT	Consultant:  SKAFS CONSULTANT (Pvt.) Limited ENGINEERING AND ENVIRONMENT CONSULTANT.
--	--

Drawing Title:	THQ CHOA SAIDEN SHAH
HOSPITAL MASTER PLAN PART 3	

Drawing No. **SKAFS/CHOA SAIDEN SHAH/06**

MASTER PLAN OF THQ HOSPITAL CHOA SAIDEN SHAH

PART 4

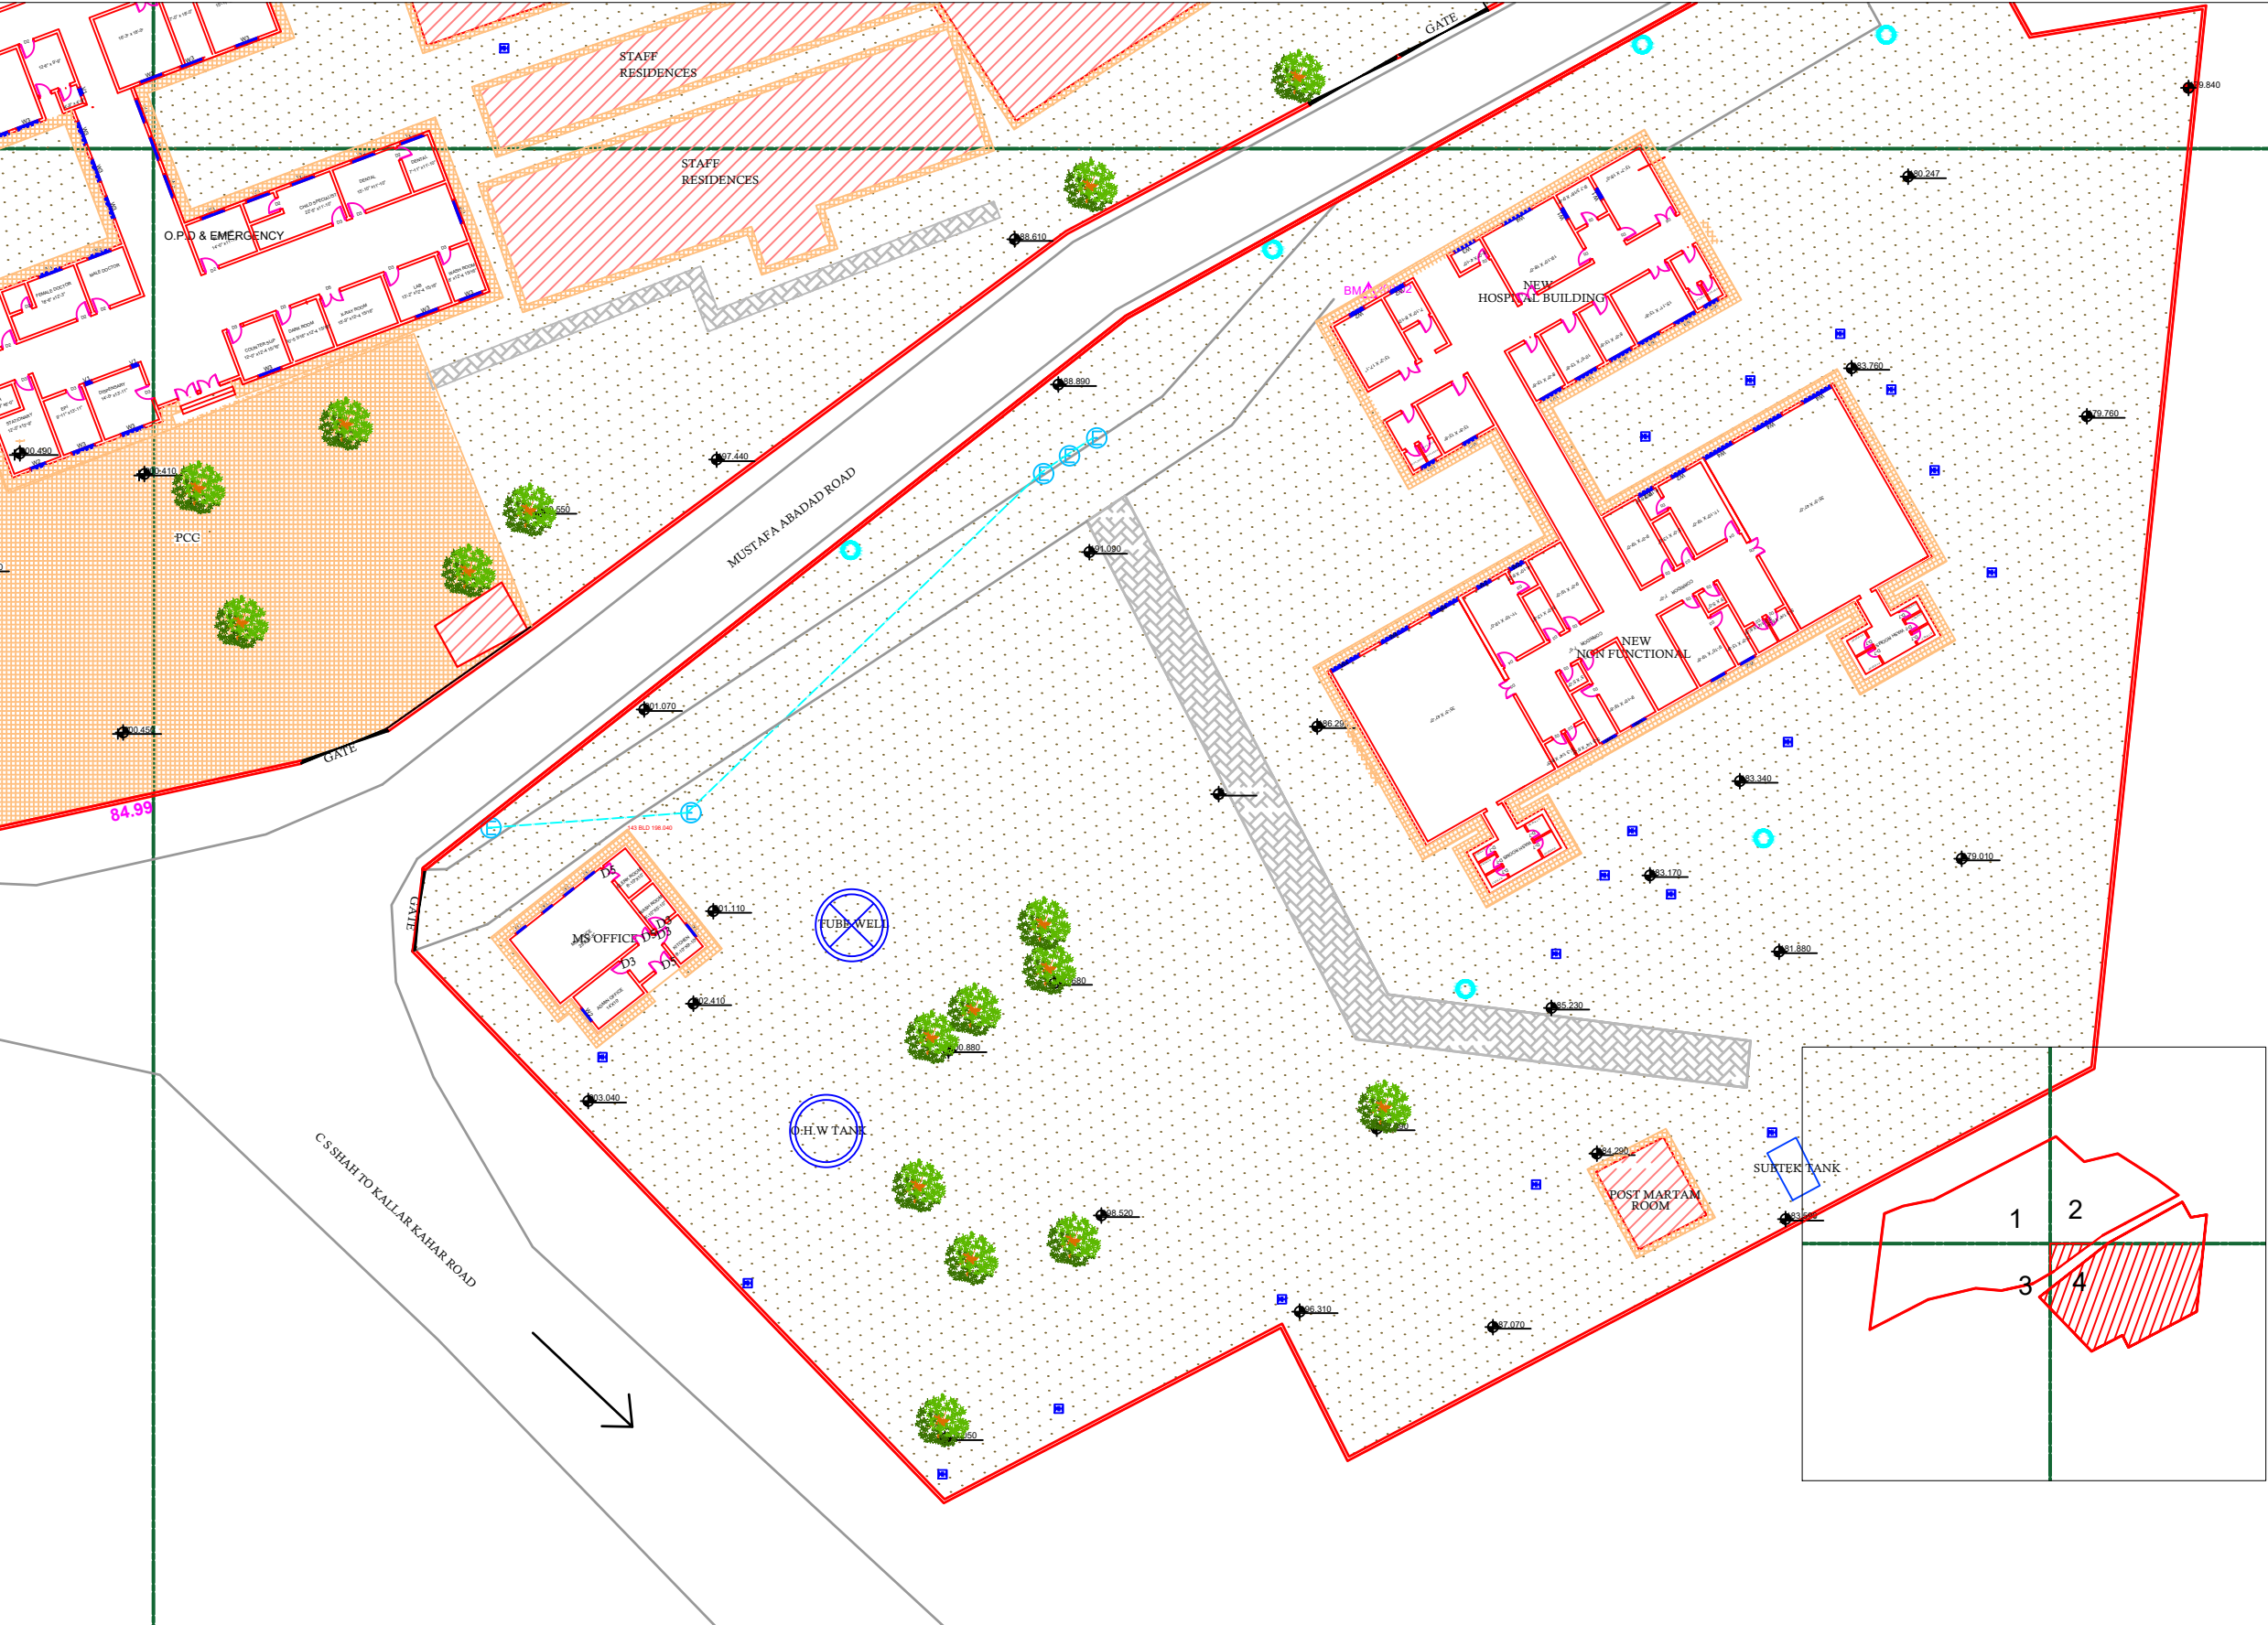

Legends:

Residential Area	
Road	
Wall	
Power Line	
OHT	
Tree	
Man Hole	
Tube Well	
Light Pole	
Lawns	
Earthen Areas	
Asphalts Roads	
Tough Pavers	
P.C.C / Plinth Protection	
Boundary Wall	
Brick Pavers / Soling	
Drain	
Tap	
Hand Pump	
Air Conditioner	
Tube Light	
Fan	
Roof Light	
Bulb	

AREA					
AREA WITHIN BOUNDARY WALL		301355.095 Sft			
AREA OF CLINICAL BLOCK		22389.3331 Sft			
PLINTH AREA OF BLOCK		22389.3331 Sft			

OPENING SCHEDULE OF DOORS AND WINDOWS					
DOORS	WIDTH	HEIGHT	WINDOWS	WIDTH	HEIGHT
D1	2'-0"	7'-0"	W1	3'-0"	5'-0"
D2	2'-6"	7'-0"	W2	4'-0"	4'-0"
D3	3'-0"	7'-0"	W3	6'-0"	6'-0"
D4	3'-6"	7'-0"	W4	8'-0"	8'-0"
D5	4'-0"	7'-0"	W5	5'-0"	5'-0"
D6	4'-6"	7'-0"	W6		
D7	5'-0"	7'-0"	W7		
D8	6'-0"	7'-0"	V1	2'-0"	2'-0"
D9	7'-0"	7'-0"	V2		

Project: **CAD MAPPING OF TEHSIL HEAD QUARTER HOSPITALS, PUNJAB**

Client:	Consultant:
GOVERNMENT OF THE PUNJAB PRIMARY & SECONDARY HEALTHCARE DEPARTMENT	SKAFS CONSULTANT (Pvt.) Limited ENGINEERING AND ENVIRONMENT CONSULTANT

Drawing Title: **THQ CHOA SAIDEN SHAH HOSPITAL MASTER PLAN PART 4**

Drawing No. **SKAFS/CHOA SAIDEN SHAH/07**

Drawing No. **SKAFS/CHOA SAIDEN SHAH/08**

CLINICAL BLOCK OF THQ HOSPITAL CHOA SAIDEN SHAH

GROUND FLOOR PART 1

Legends:	
Residential Area	
Road	
Wall	
Power Line	
OHT	
Tree	
Man Hole	
Tube Well	
Light Pole	
Lawns	
Earthen Areas	
Asphalts Roads	
Tough Pavers	
P.C.C / Plinth Protection	
Boundary Wall	
Brick Pavers / Soling	
Drain	
Tap	
Hand Pump	
Air Conditioner	
Tube Light	
Fan	
Roof Light	
Bulb	

AREA	
AREA WITHIN BOUNDARY WALL	301355.095 Sft
AREA OF CLINICAL BLOCK	22389.3331 Sft
PLINTH AREA OF BLOCK	22389.3331 Sft



OPENING SCHEDULE OF DOORS AND WINDOWS					
DOORS	WIDTH	HEIGHT	WINDOWS	WIDTH	HEIGHT
D1	2'-0"	7'-0"	W1	3'-0"	5'-0"
D2	2'-6"	7'-0"	W2	4'-0"	4'-0"
D3	3'-0"	7'-0"	W3	6'-0"	6'-0"
D4	3'-6"	7'-0"	W4	8'-0"	8'-0"
D5	4'-0"	7'-0"	W5	5'-0"	5'-0"
D6	4'-6"	7'-0"	W6		
D7	5'-0"	7'-0"	W7		
D8	6'-0"	7'-0"	V1	2'-0"	2'-0"
D9	7'-0"	7'-0"	V2		

Project:
**CAD MAPPING OF TEHSIL
HEAD QUARTER HOSPITALS,
PUNJAB**


Client: GOVERNMENT OF THE PUNJAB PRIMARY & SECONDARY HEALTHCARE DEPARTMENT	Consultant: SKAFS CONSULTANT (Pvt.) Limited ENGINEERING AND ENVIRONMENT CONSULTANT
---	--

Drawing Title:
**THQ CHOA SAIDEN SHAH
CLINICAL BLOCK PLAN (PART 1)**

Drawing No.
SKAFS/CHOA SAIDEN SHAH/09

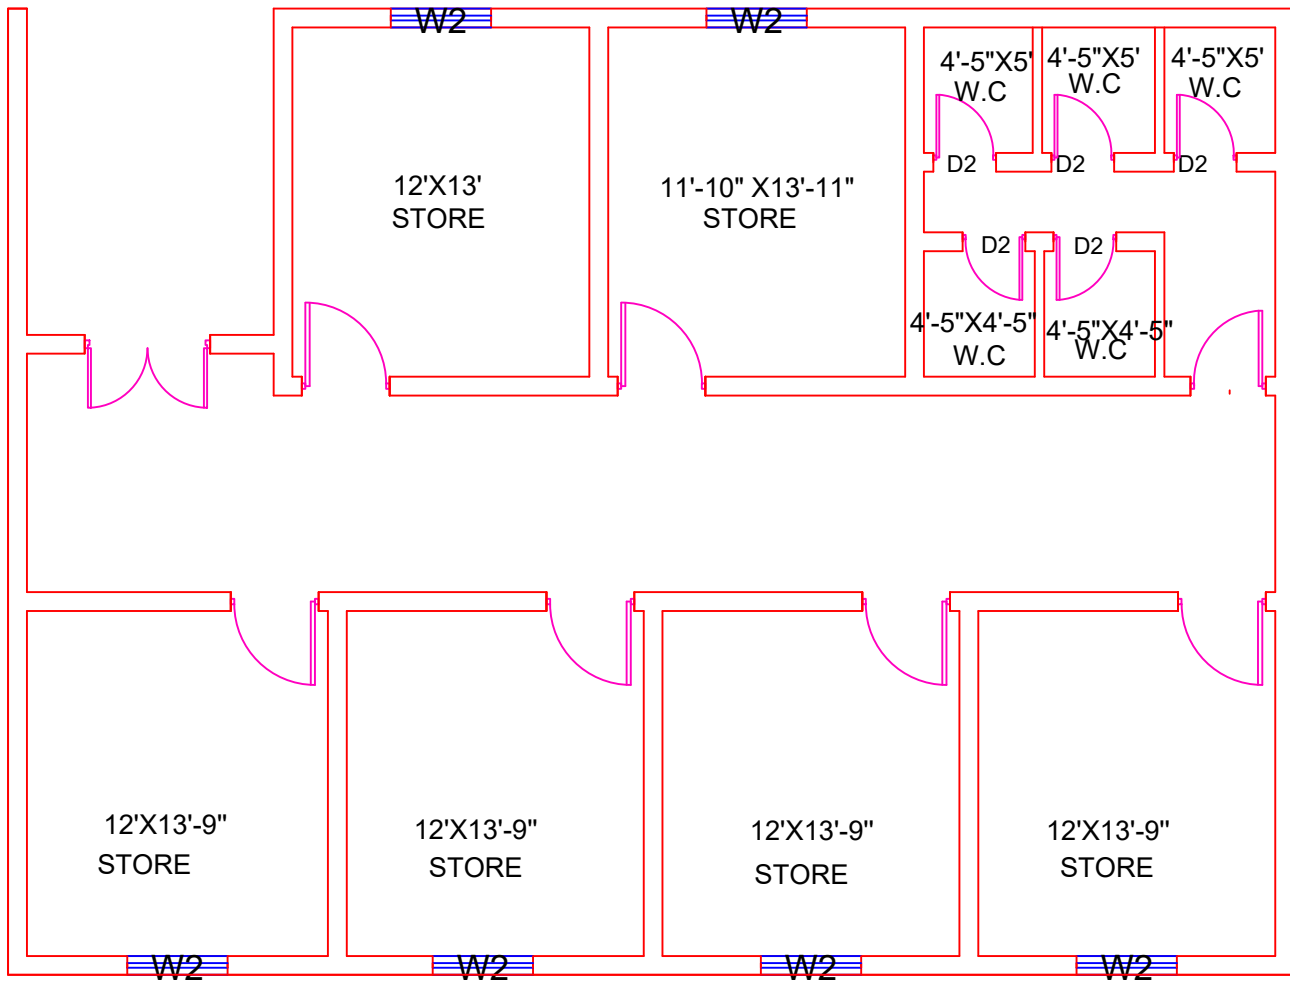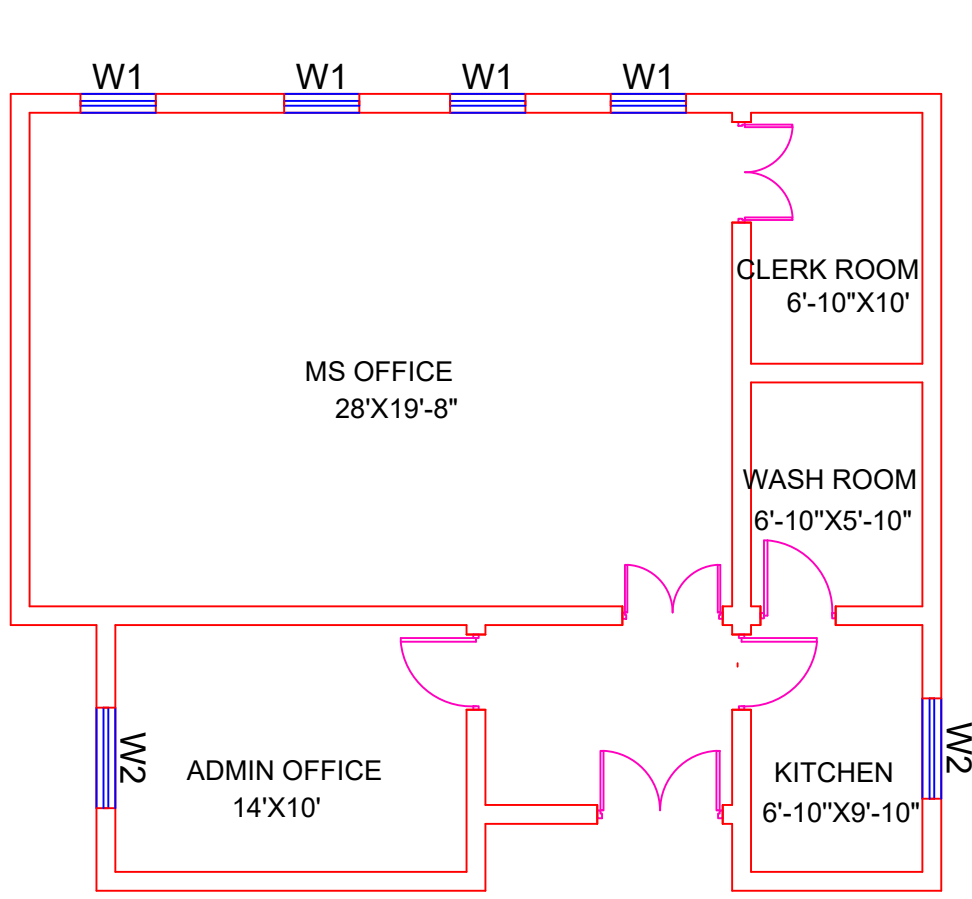


CLINICAL BLOCK OF THQ HOSPITAL CHOA SAIDEN SHAH
GROUND FLOOR PART 2

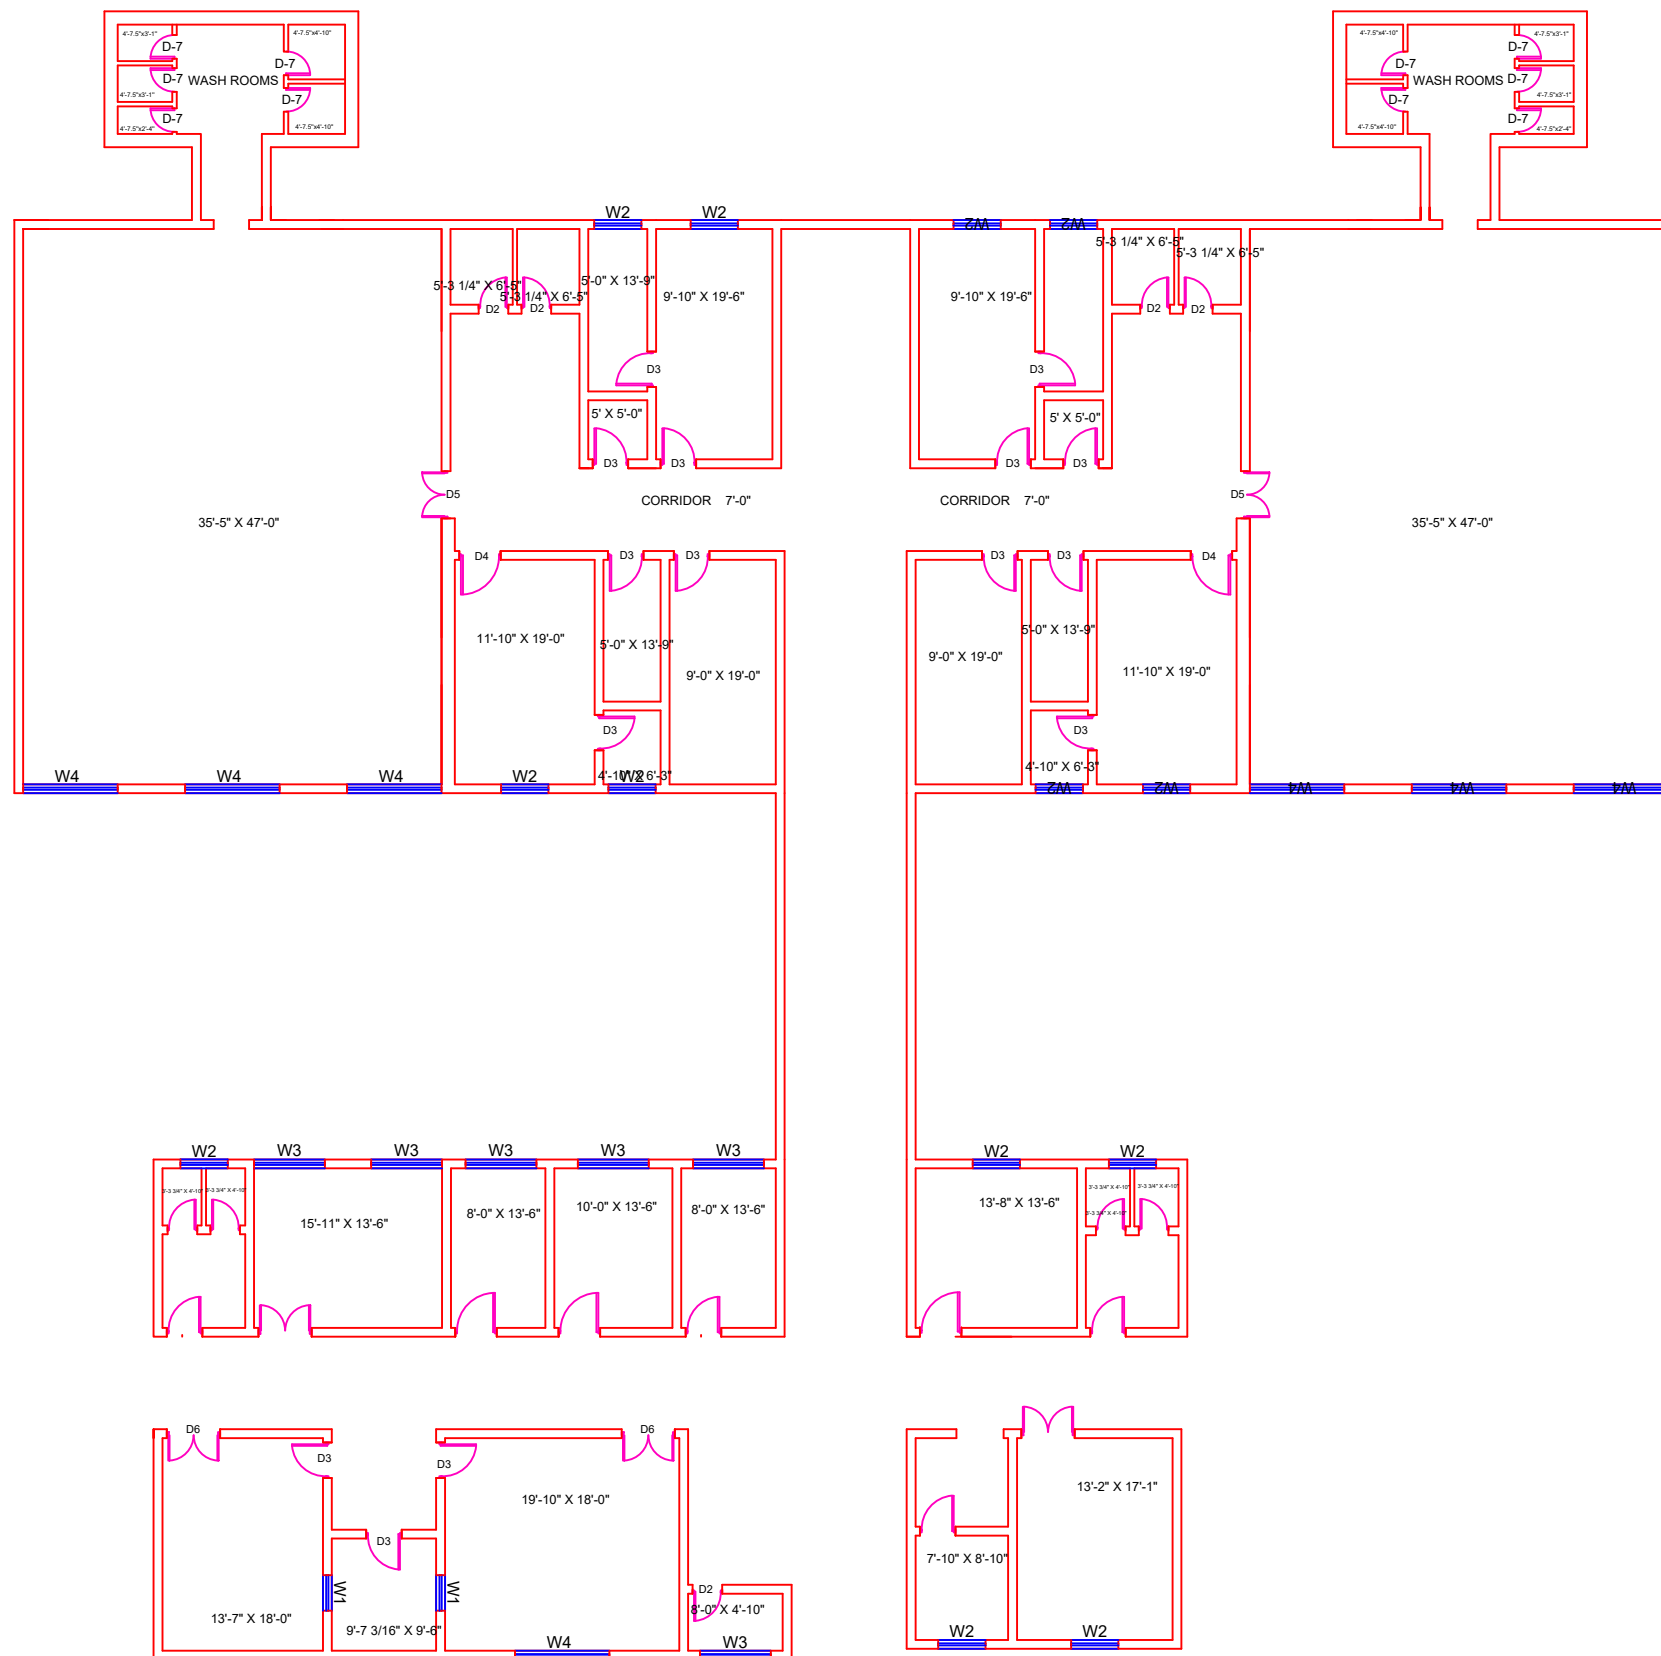

NEW
NON FUNCTIONAL

 Legends:

Residential Area	
Road	
Wall	
Power Line	
OHT	
Tree	
Man Hole	
Tube Well	
Light Pole	
Lawns	
Earthen Areas	
Asphalts Roads	
Tough Pavers	
P.C.C / Plinth Protection	
Boundary Wall	
Brick Pavers / Soling	
Drain	
Tap	
Hand Pump	
Air Conditioner	
Tube Light	
Fan	
Roof Light	
Bulb	

AREA	
AREA WITHIN BOUNDARY WALL	301355.095 Sft
AREA OF CLINICAL BLOCK	22389.3331 Sft
PLINTH AREA OF BLOCK	22389.3331 Sft

OPENING SCHEDULE OF DOORS AND WINDOWS					
DOORS	WIDTH	HEIGHT	WINDOWS	WIDTH	HEIGHT
D1	2'-0"	7'-0"	W1	3'-0"	5'-0"
D2	2'-6"	7'-0"	W2	4'-0"	4'-0"
D3	3'-0"	7'-0"	W3	6'-0"	6'-0"
D4	3'-6"	7'-0"	W4	8'-0"	8'-0"
D5	4'-0"	7'-0"	W5	5'-0"	5'-0"
D6	4'-6"	7'-0"	W6		
D7	5'-0"	7'-0"	W7		
D8	6'-0"	7'-0"	V1	2'-0"	2'-0"
D9	7'-0"	7'-0"	V2		

Project:
**CAD MAPPING OF TEHSIL
HEAD QUARTER HOSPITALS,
PUNJAB**


Client:  GOVERNMENT OF THE PUNJAB PRIMARY & SECONDARY HEALTHCARE DEPARTMENT	Consultant:  SKAFS CONSULTANT (Pvt.) Limited <i>ENGINEERING AND ENVIRONMENT CONSULTANT</i>
--	---

Drawing Title:	THQ CHOA SAIDEN SHAH CLINICAL BLOCK PLAN (PART 2)
----------------	--

Drawing No. **SKAFS/CHOA SAIDEN SHAH/10**

CLINICAL BLOCK OF THQ HOSPITAL CHOA SAIDEN SHAH

GROUND FLOOR PART 3

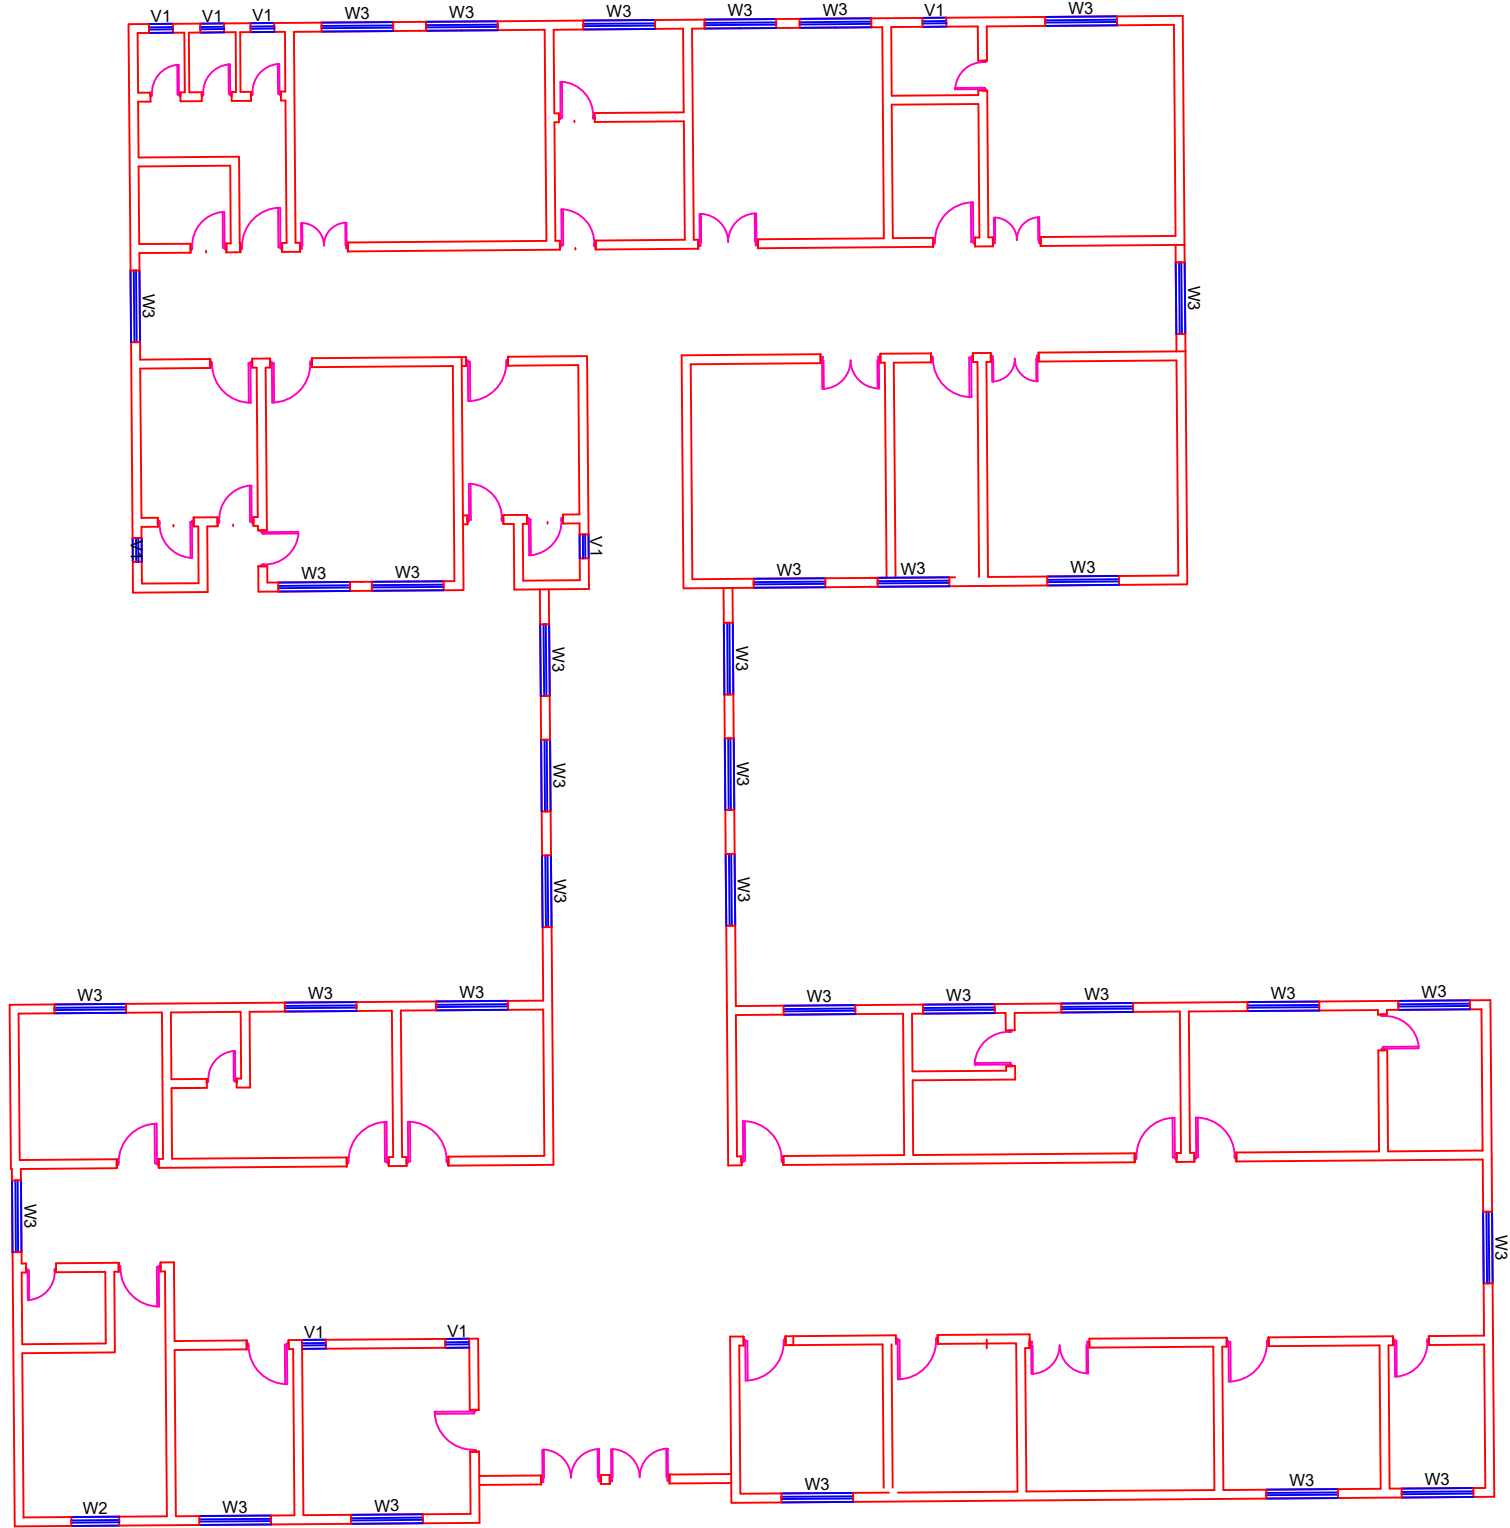

Legends:

Residential Area	
Road	
Wall	
Power Line	
OHT	
Tree	
Man Hole	
Tube Well	
Light Pole	
Lawns	
Earthen Areas	
Asphalts Roads	
Tough Pavers	
P.C.C / Plinth Protection	
Boundary Wall	
Brick Pavers / Soling	
Drain	
Tap	
Hand Pump	
Air Conditioner	
Tube Light	
Fan	
Roof Light	
Bulb	

AREA	
AREA WITHIN BOUNDARY WALL	301355.095 Sft
AREA OF CLINICAL BLOCK	22389.3331 Sft
PLINTH AREA OF BLOCK	22389.3331 Sft

OPENING SCHEDULE OF DOORS AND WINDOWS					
DOORS	WIDTH	HEIGHT	WINDOWS	WIDTH	HEIGHT
D1	2'-0"	7'-0"	W1	3'-0"	5'-0"
D2	2'-6"	7'-0"	W2	4'-0"	4'-0"
D3	3'-0"	7'-0"	W3	6'-0"	6'-0"
D4	3'-6"	7'-0"	W4	8'-0"	8'-0"
D5	4'-0"	7'-0"	W5	5'-0"	5'-0"
D6	4'-6"	7'-0"	W6		
D7	5'-0"	7'-0"	W7		
D8	6'-0"	7'-0"	V1	2'-0"	2'-0"
D9	7'-0"	7'-0"	V2		

Project:
**CAD MAPPING OF TEHSIL
HEAD QUARTER HOSPITALS,
PUNJAB**

Client: GOVERNMENT OF THE PUNJAB PRIMARY & SECONDARY HEALTHCARE DEPARTMENT	Consultant: SKAFS CONSULTANT (Pvt.) Limited ENGINEERING AND ENVIRONMENT CONSULTANT
---	--

Drawing Title:
**THQ CHOA SAIDEN SHAH
CLINICAL BLOCK PLAN (PART 3)**

Drawing No.
SKAFS/CHOA SAIDEN SHAH/11

ELECTRICAL LAYOUT PLAN OF THQ HOSPITAL

CHOA SAIDEN SHAH GROUND FLOOR



Legends:

Residential Area	
Road	
Wall	
Power Line	
OHT	
Tree	
Man Hole	
Tube Well	
Light Pole	
Lawns	
Earthen Areas	
Asphalts Roads	
Tough Pavers	
P.C.C / Plinth Protection	
Boundary Wall	
Brick Pavers / Soling	
Drain	
Tap	
Hand Pump	
Air Conditioner	
Tube Light	
Fan	
Roof Light	
Bulb	

AREA	
AREA WITHIN BOUNDARY WALL	301355.095 Sft
AREA OF CLINICAL BLOCK	22389.3331 Sft
PLINTH AREA OF BLOCK	22389.3331 Sft

OPENING SCHEDULE OF DOORS AND WINDOWS					
DOORS	WIDTH	HEIGHT	WINDOWS	WIDTH	HEIGHT
D1	2'-0"	7'-0"	W1	3'-0"	5'-0"
D2	2'-6"	7'-0"	W2	4'-0"	4'-0"
D3	3'-0"	7'-0"	W3	6'-0"	6'-0"
D4	3'-6"	7'-0"	W4	8'-0"	8'-0"
D5	4'-0"	7'-0"	W5	5'-0"	5'-0"
D6	4'-6"	7'-0"	W6		
D7	5'-0"	7'-0"	W7		
D8	6'-0"	7'-0"	V1	2'-0"	2'-0"
D9	7'-0"	7'-0"	V2		

Project:
**CAD MAPPING OF TEHSIL
HEAD QUARTER HOSPITALS,
PUNJAB**

Client: GOVERNMENT OF THE PUNJAB PRIMARY & SECONDARY HEALTHCARE DEPARTMENT	Consultant: SKAFS CONSULTANT (Pvt.) Limited ENGINEERING AND ENVIRONMENT CONSULTANT
---	--

Drawing Title:
**THQ CHOA SAIDEN SHAH
ELECTRICAL PLAN (GROUND FLOOR)**

Drawing No.
SKAFS/CHOA SAIDEN SHAH/14