


MASTER PLAN OF THQ HOSPITAL DARYA KHAN

PART 1

PART 2

PART 3

PART 4

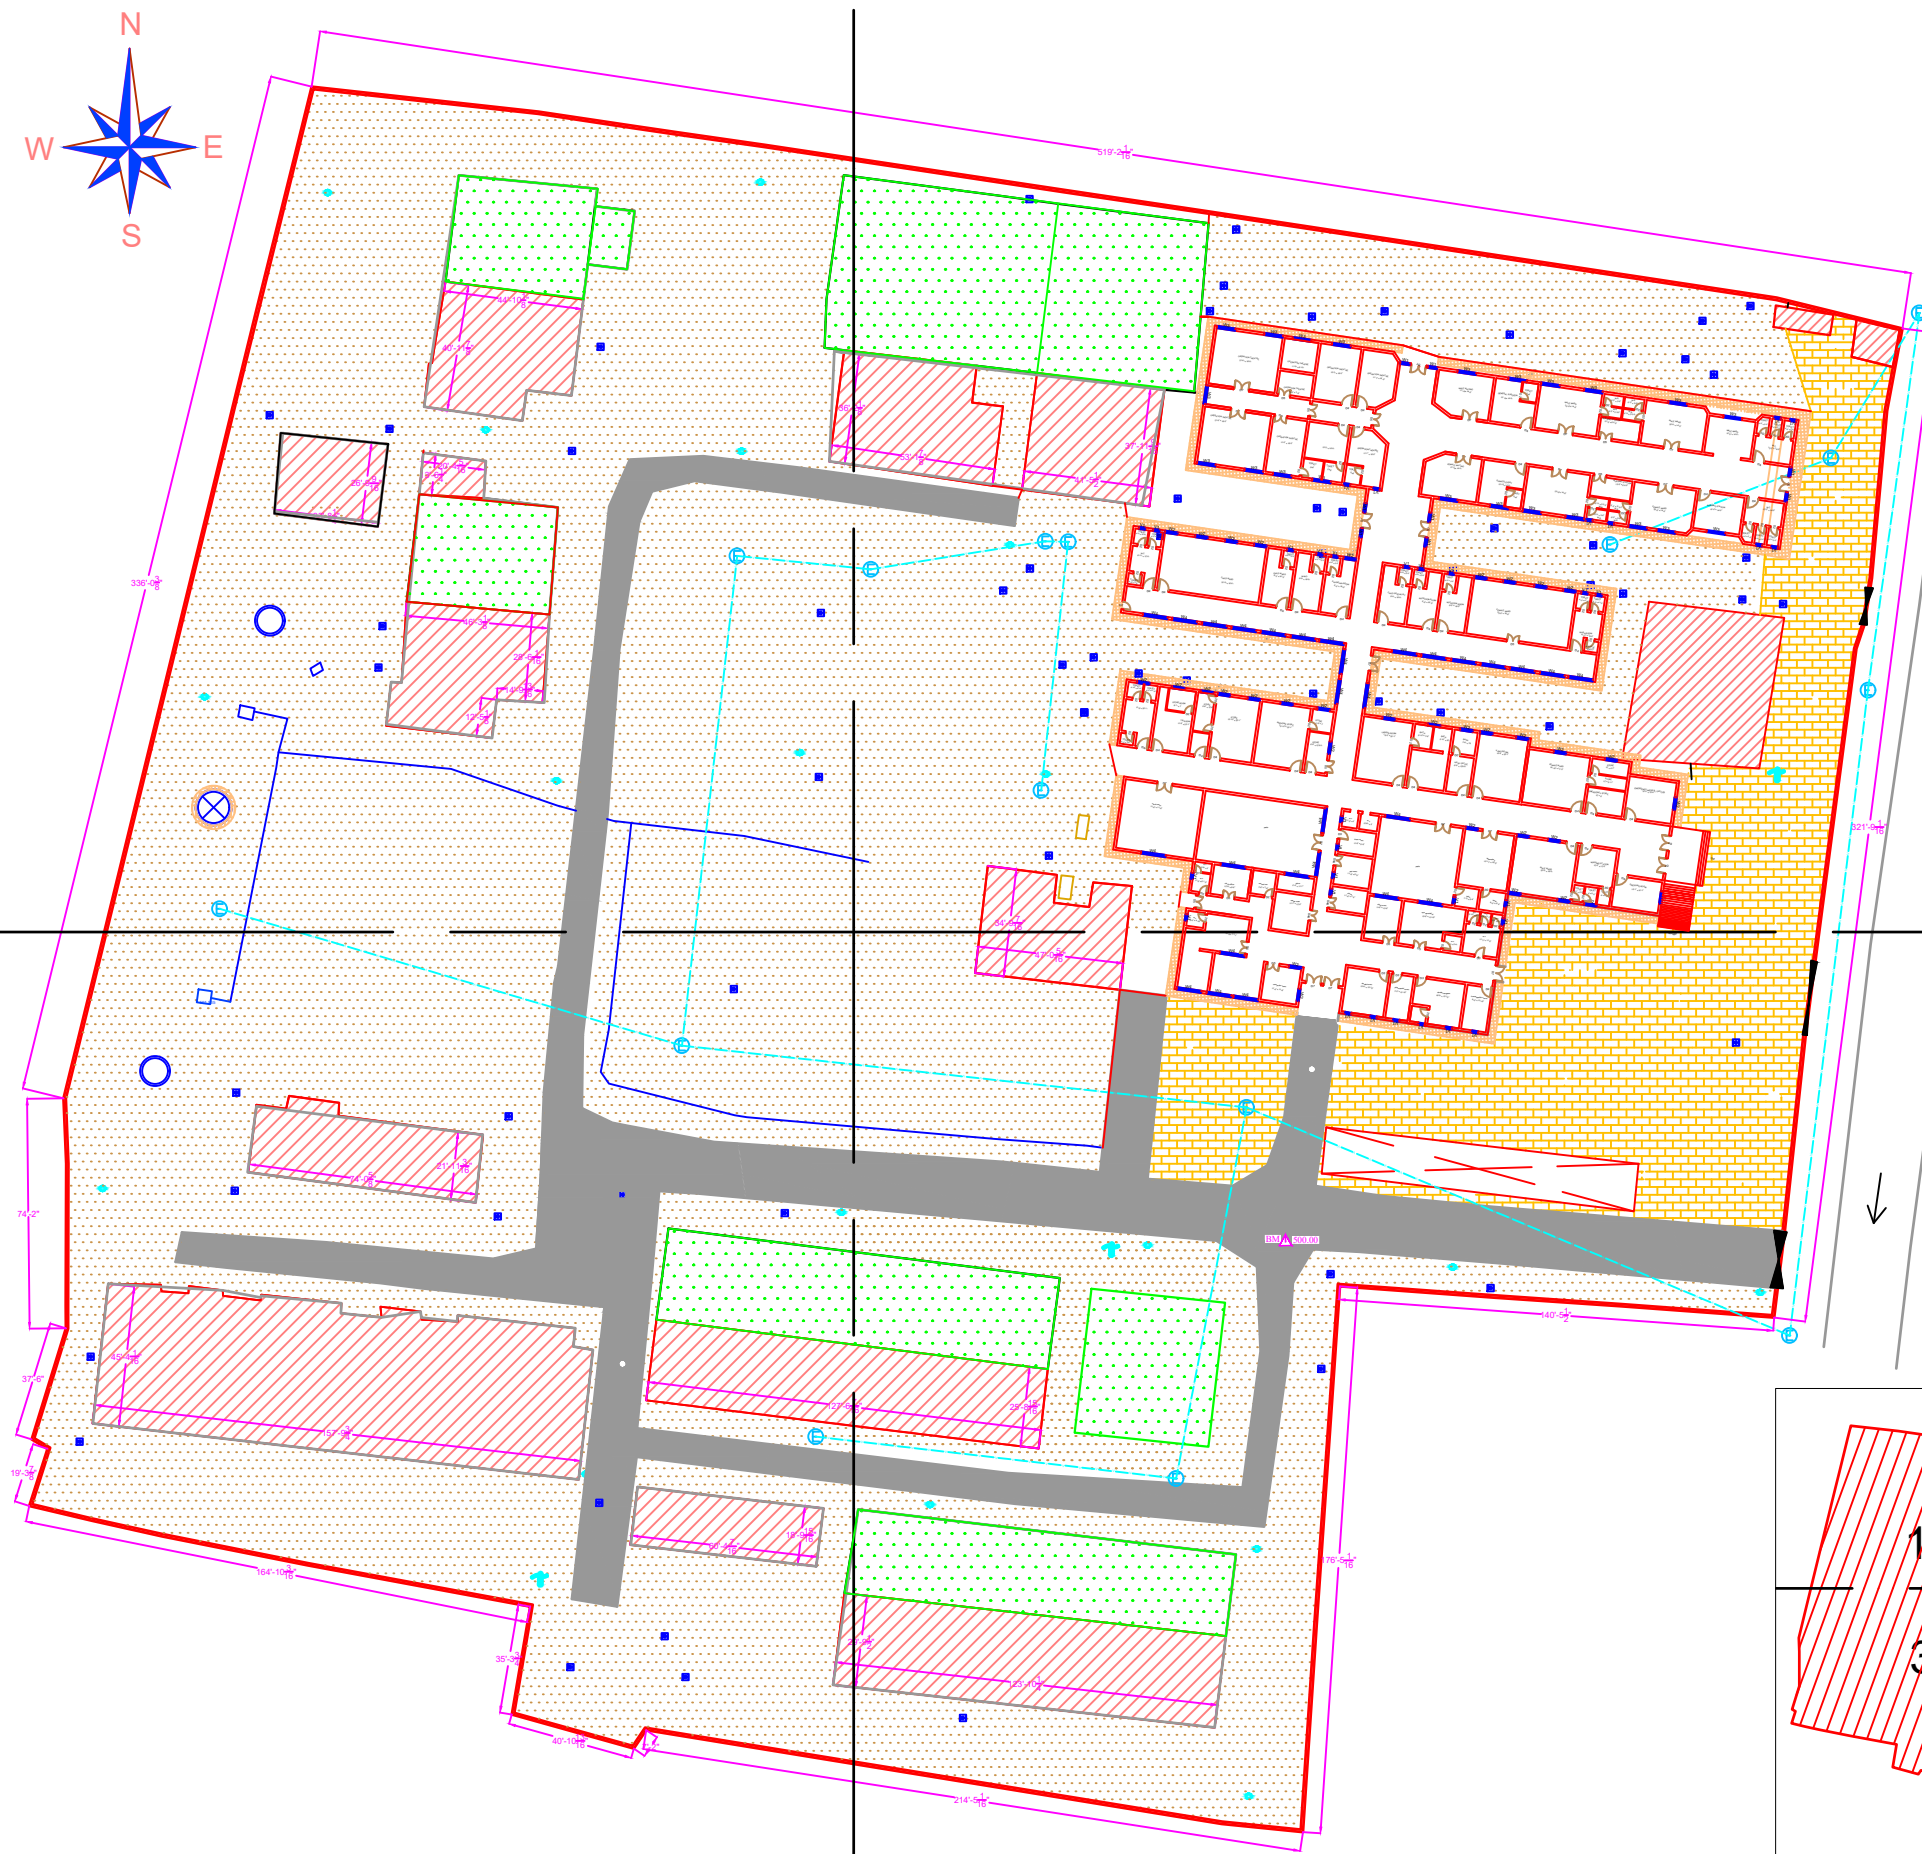

Legends:

Residential Area	
Road	
Wall	
Power Line	
OHT	
Tree	
Man Hole	
Tube Well	
Light Pole	
Lawns	
Earthen Areas	
Asphalts Roads	
Tough Pavers	
P.C.C / Plinth Protection	
Boundary Wall	
Brick Pavers / Soling	
Drain	
Tap	
Hand Pump	
Air Conditioner	
Tube Light	
Fan	
Roof Light	
Bulb	

AREA	
AREA WITHIN BOUNDARY WALL	245075.277 Sft
AREA OF CLINICAL BLOCK	26851.4273 Sft
PLINTH AREA OF BLOCK	3244.5719 Sft


OPENING SCHEDULE OF DOORS AND WINDOWS					
DOORS	WIDTH	HEIGHT	WINDOWS	WIDTH	HEIGHT
D1	2'-0"	7'-0"	W1	3'-0"	5'-0"
D2	2'-6"	7'-0"	W2	4'-0"	4'-0"
D3	3'-0"	7'-0"	W3	6'-0"	6'-0"
D4	3'-6"	7'-0"	W4	8'-0"	8'-0"
D5	4'-0"	7'-0"	W5	5'-0"	5'-0"
D6	4'-6"	7'-0"	W6		
D7	5'-0"	7'-0"	W7		
D8	6'-0"	7'-0"	V1	2'-0"	2'-0"
D9	7'-0"	7'-0"	V2		

Project:
**CAD MAPPING OF TEHSIL
HEAD QUARTER HOSPITALS,
PUNJAB**

Client: GOVERNMENT OF THE PUNJAB PRIMARY & SECONDARY HEALTHCARE DEPARTMENT	Consultant: SKAFS CONSULTANT (Pvt.) Limited ENGINEERING AND ENVIRONMENT CONSULTANT
---	--




Drawing Title:
**THQ DARYA KHAN
HOSPITAL MASTER PLAN**

Drawing No.
SKAFS/DARYA KHAN03

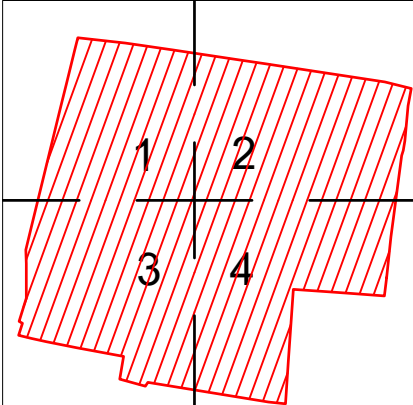

MASTER PLAN OF THQ HOSPITAL DARYA KHAN

PART 1

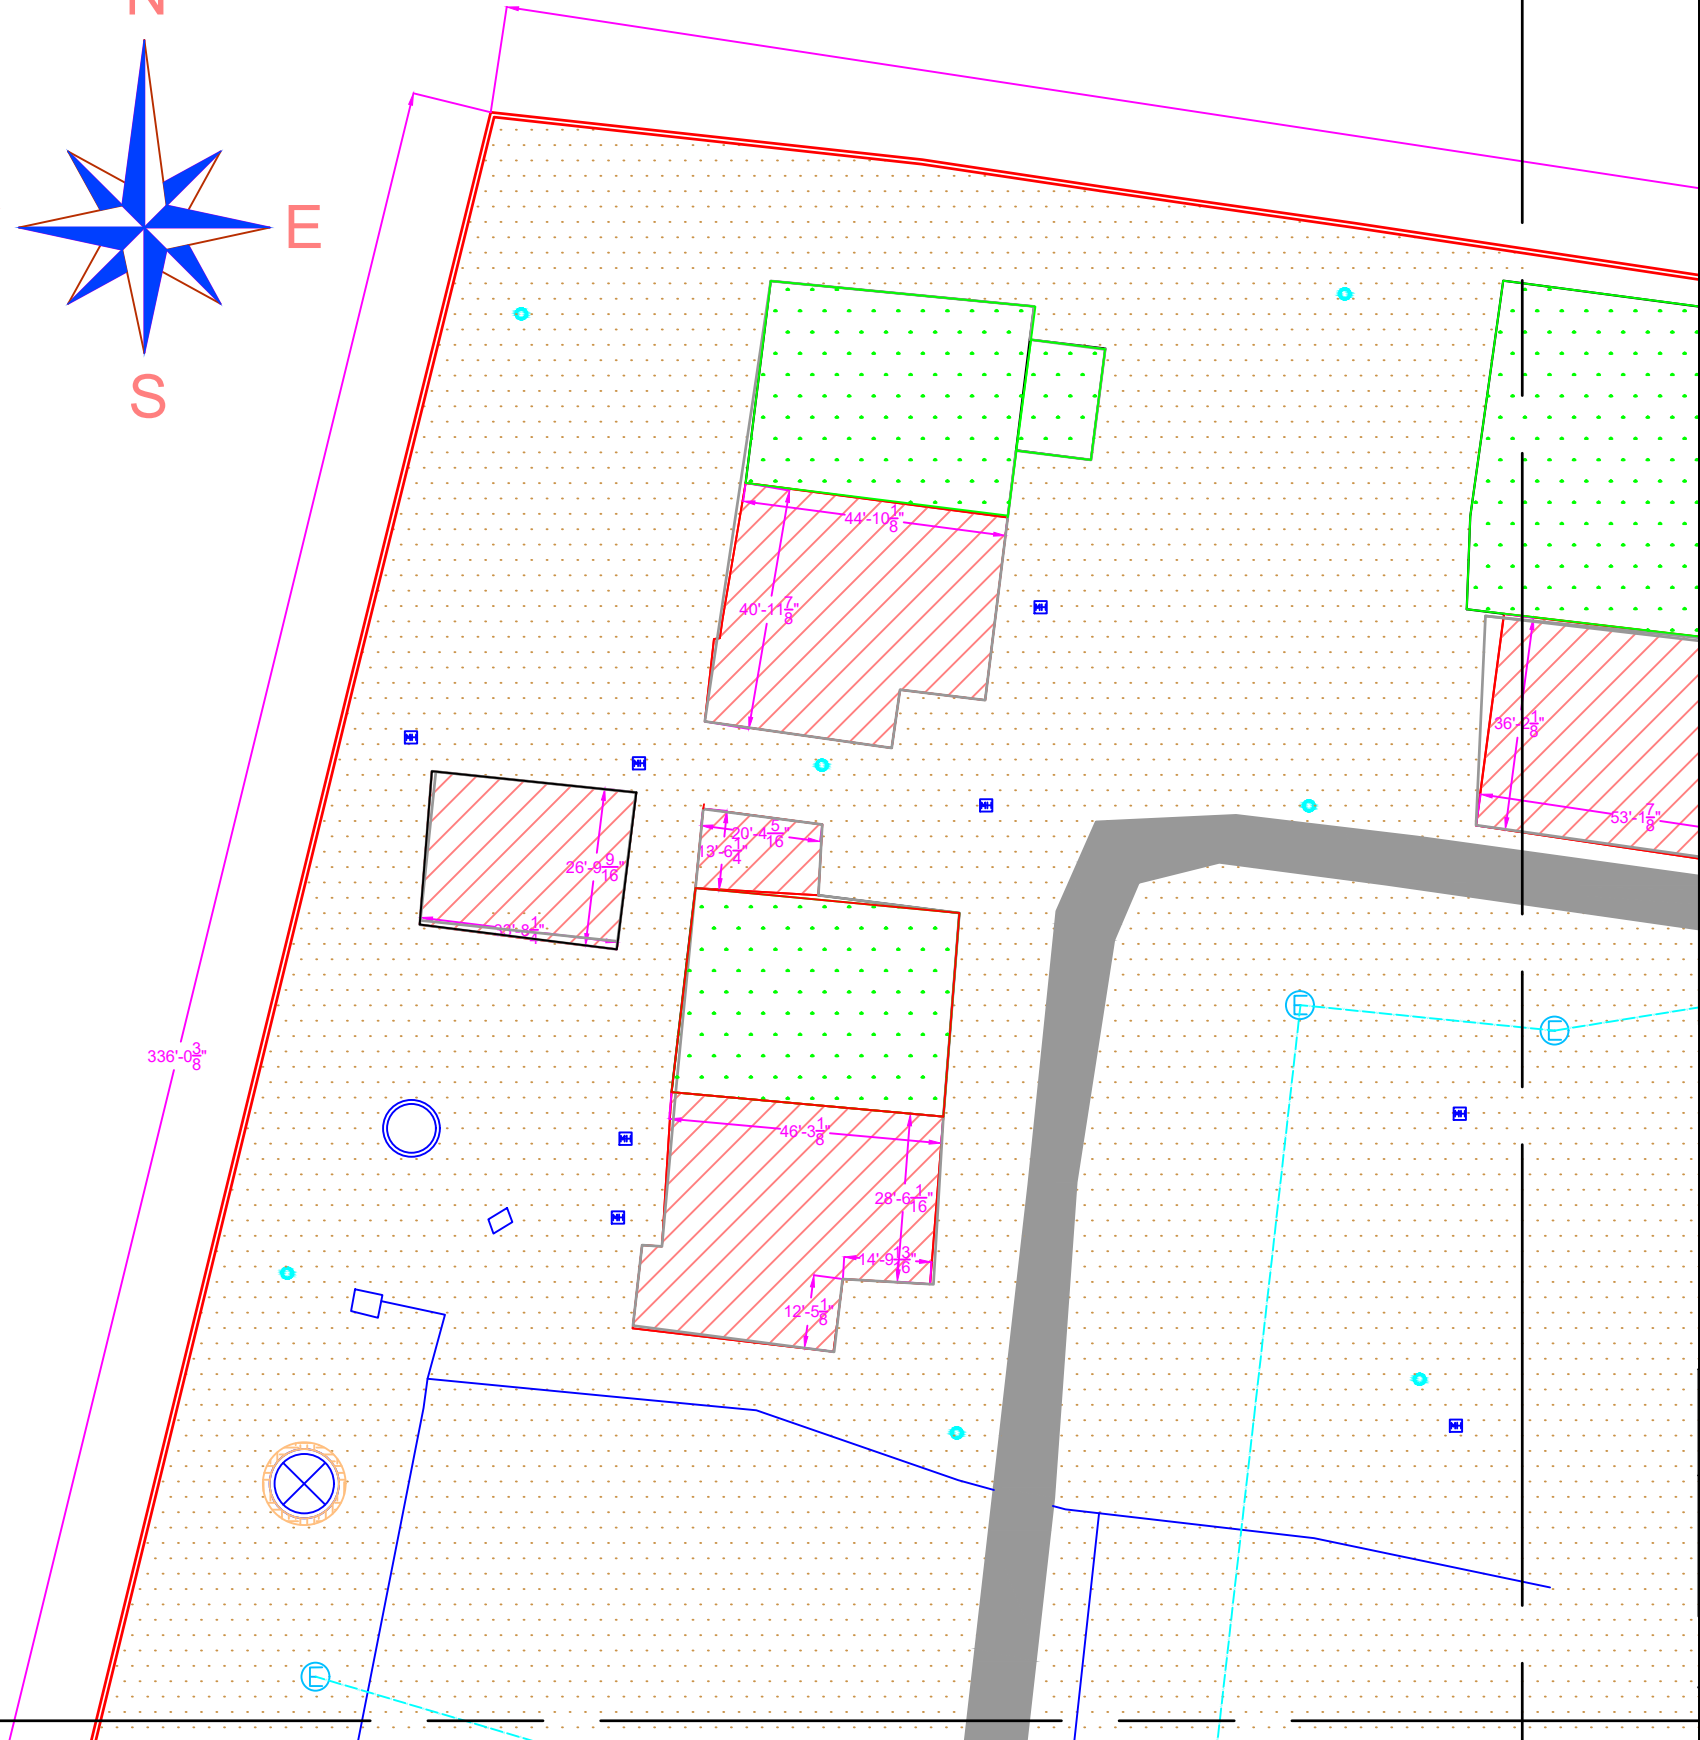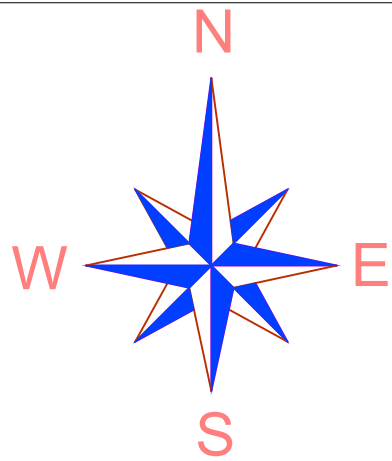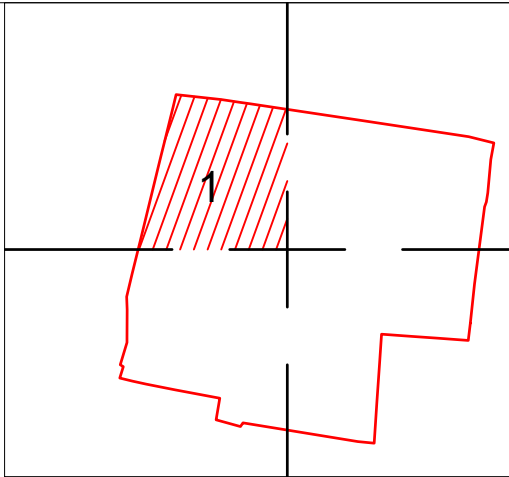

Legends:

Residential Area	
Road	
Wall	
Power Line	
OHT	
Tree	
Man Hole	
Tube Well	
Light Pole	
Lawns	
Earthen Areas	
Asphalts Roads	
Tough Pavers	
P.C.C / Plinth Protection	
Boundary Wall	
Brick Pavers / Soling	
Drain	
Tap	
Hand Pump	
Air Conditioner	
Tube Light	
Fan	
Roof Light	
Bulb	

AREA	
AREA WITHIN BOUNDARY WALL	245075.277 Sft
AREA OF CLINICAL BLOCK	26851.4273 Sft
PLINTH AREA OF BLOCK	3244.5719 Sft

OPENING SCHEDULE OF DOORS AND WINDOWS					
DOORS	WIDTH	HEIGHT	WINDOWS	WIDTH	HEIGHT
D1	2'-0"	7'-0"	W1	3'-0"	5'-0"
D2	2'-6"	7'-0"	W2	4'-0"	4'-0"
D3	3'-0"	7'-0"	W3	6'-0"	6'-0"
D4	3'-6"	7'-0"	W4	8'-0"	8'-0"
D5	4'-0"	7'-0"	W5	5'-0"	5'-0"
D6	4'-6"	7'-0"	W6		
D7	5'-0"	7'-0"	W7		
D8	6'-0"	7'-0"	V1	2'-0"	2'-0"
D9	7'-0"	7'-0"	V2		

Project:
**CAD MAPPING OF TEHSIL
HEAD QUARTER HOSPITALS,
PUNJAB**


Client:	Consultant:
 GOVERNMENT OF THE PUNJAB PRIMARY & SECONDARY HEALTHCARE DEPARTMENT	 SKAFS CONSULTANT (Pvt.) Limited ENGINEERING AND ENVIRONMENT CONSULTANT

Drawing Title:
**THQ DARYA KHAN
HOSPITAL MASTER PLAN PART 1**

Drawing No.
SKAFS/DARYA KHAN04

MASTER PLAN OF THQ HOSPITAL DARYA KHAN

PART 2

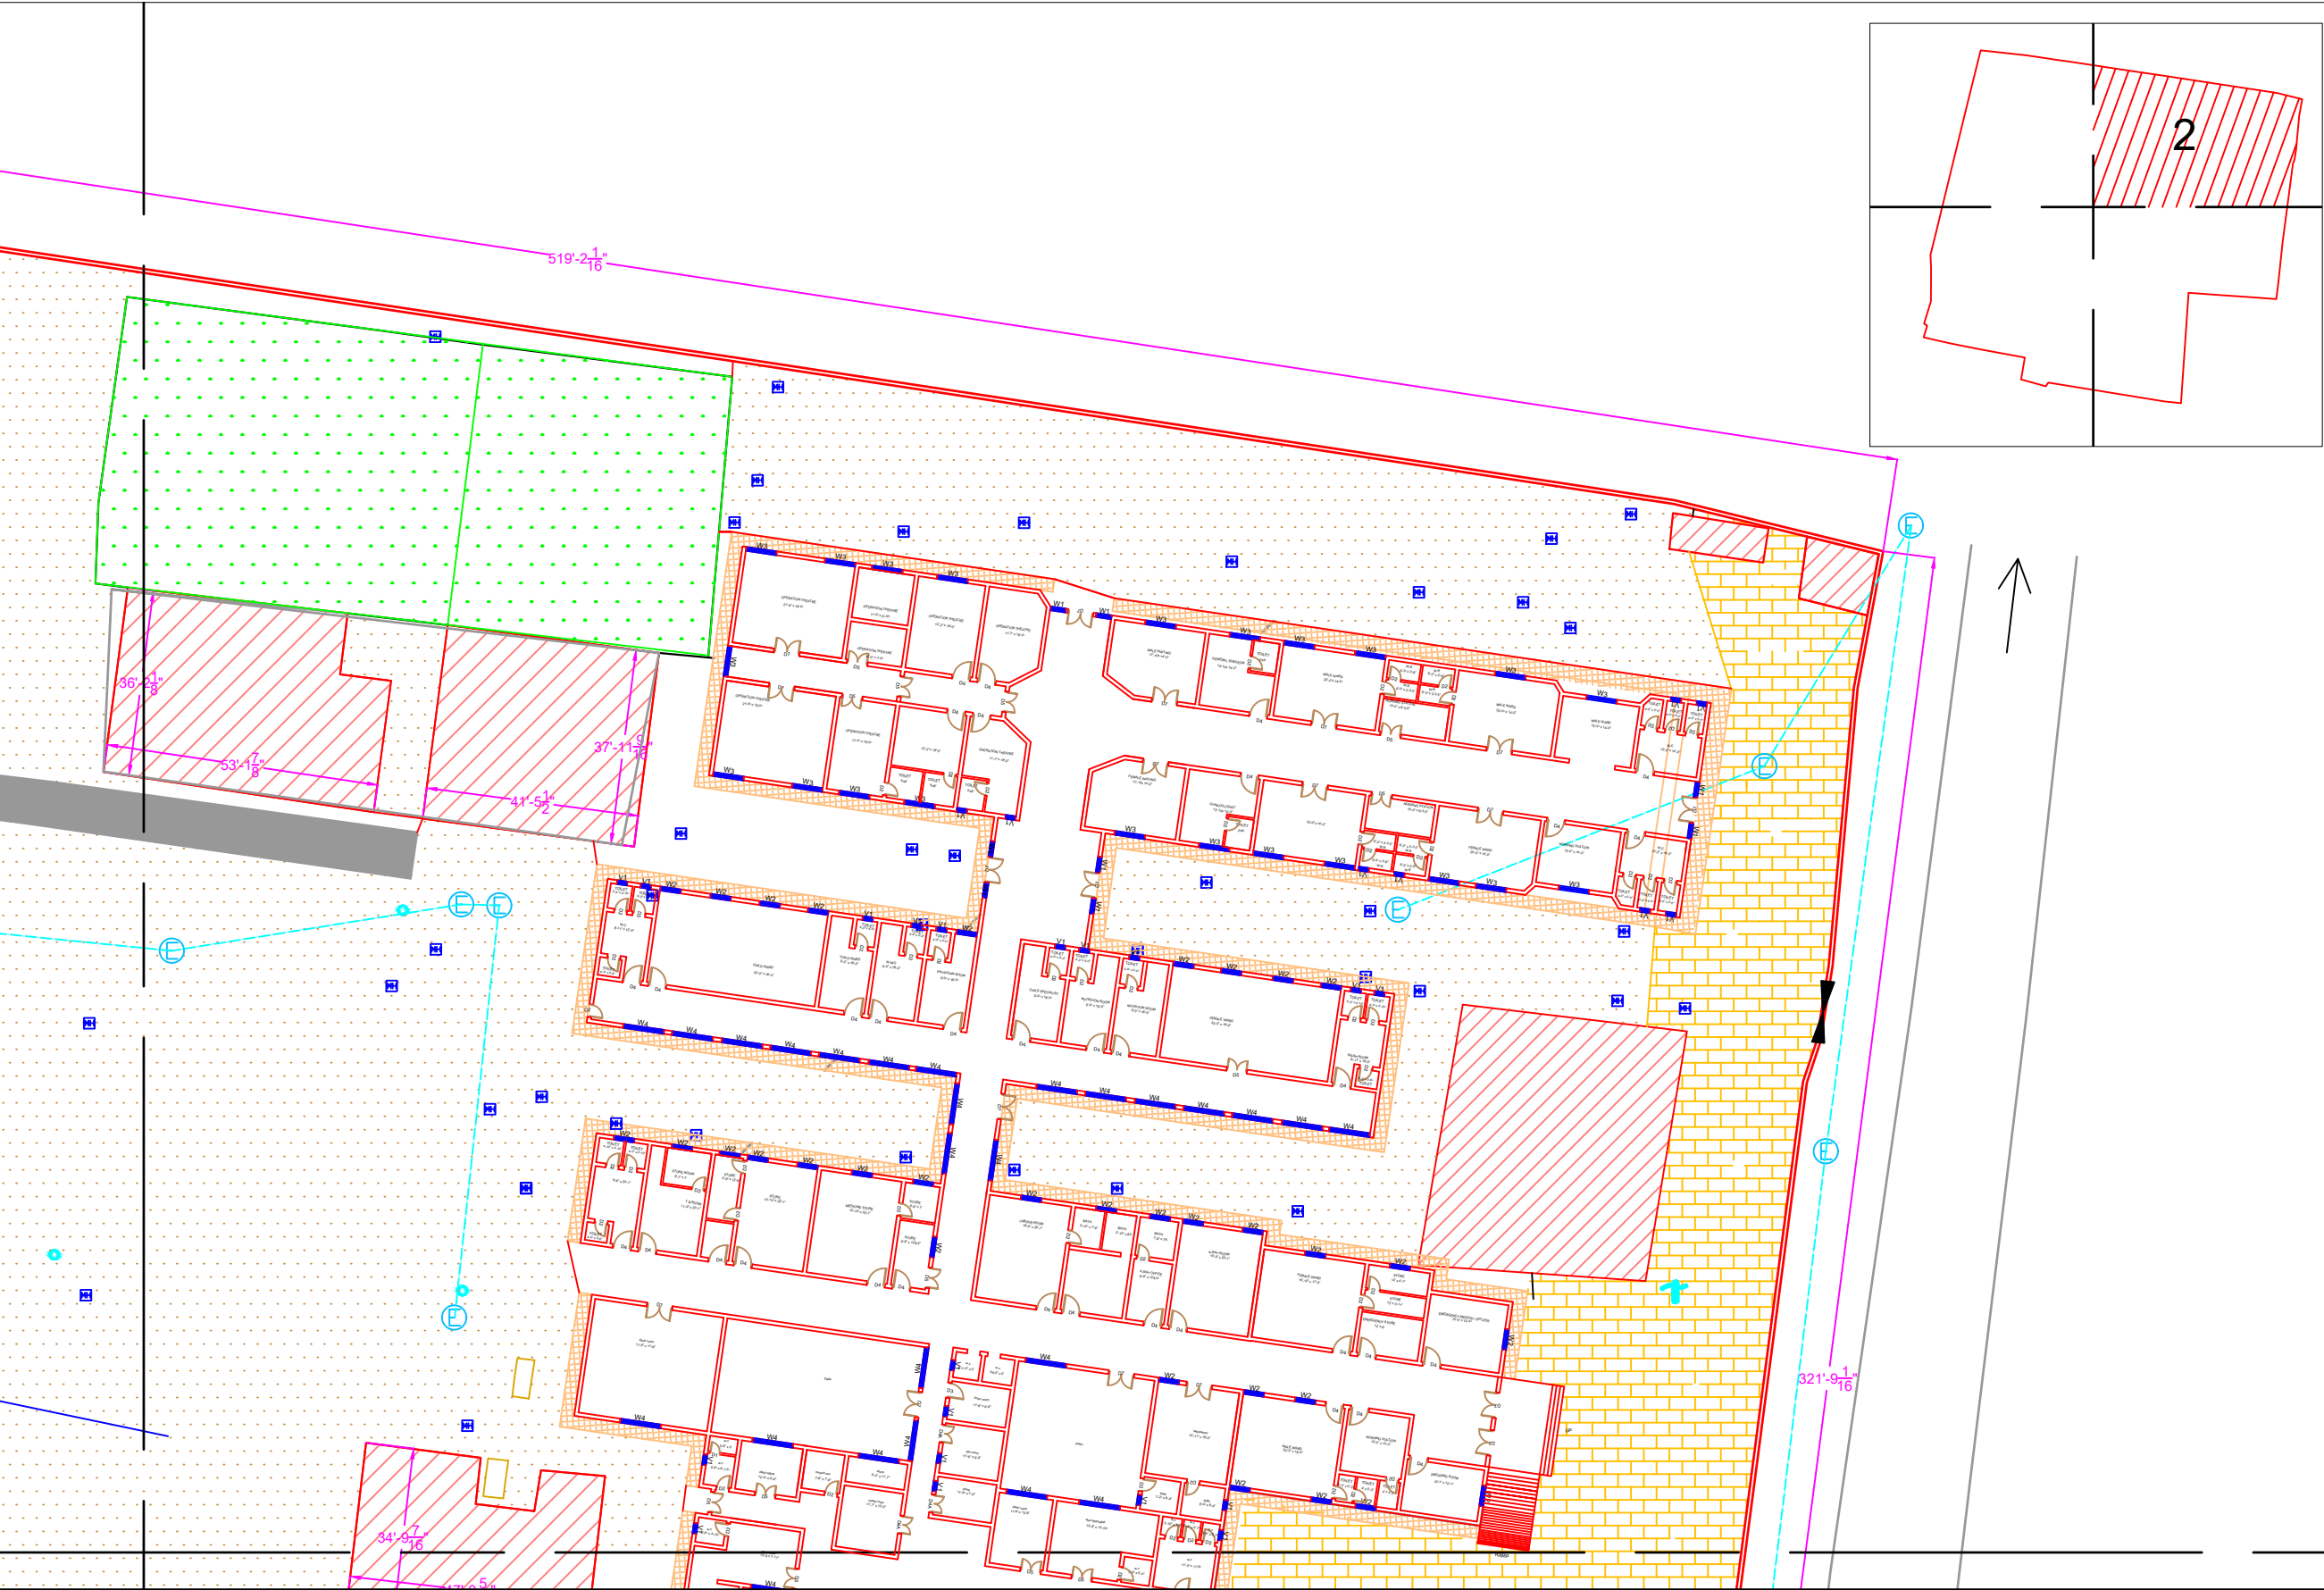

Legends:

Residential Area	
Road	
Wall	
Power Line	
OHT	
Tree	
Man Hole	
Tube Well	
Light Pole	
Lawns	
Earthen Areas	
Asphalts Roads	
Tough Pavers	
P.C.C / Plinth Protection	
Boundary Wall	
Brick Pavers / Soling	
Drain	
Tap	
Hand Pump	
Air Conditioner	
Tube Light	
Fan	
Roof Light	
Bulb	

AREA					
AREA WITHIN BOUNDARY WALL		245075.277 Sft			
AREA OF CLINICAL BLOCK		26851.4273 Sft			
PLINTH AREA OF BLOCK		3244.5719 Sft			

OPENING SCHEDULE OF DOORS AND WINDOWS					
DOORS	WIDTH	HEIGHT	WINDOWS	WIDTH	HEIGHT
D1	2'-0"	7'-0"	W1	3'-0"	5'-0"
D2	2'-6"	7'-0"	W2	4'-0"	4'-0"
D3	3'-0"	7'-0"	W3	6'-0"	6'-0"
D4	3'-6"	7'-0"	W4	8'-0"	8'-0"
D5	4'-0"	7'-0"	W5	5'-0"	5'-0"
D6	4'-6"	7'-0"	W6		
D7	5'-0"	7'-0"	W7		
D8	6'-0"	7'-0"	V1	2'-0"	2'-0"
D9	7'-0"	7'-0"	V2		

Project:

CAD MAPPING OF TEHSIL HEAD QUARTER HOSPITALS, PUNJAB

Client:

GOVERNMENT OF THE PUNJAB
PRIMARY & SECONDARY
HEALTHCARE DEPARTMENT

Consultant:

SKAFS CONSULTANT (Pvt.)
Limited
ENGINEERING AND ENVIRONMENT
CONSULTANT


Drawing Title:

**THQ DARYA KHAN
HOSPITAL MASTER PLAN PART 2**

Drawing No. **SKAFS/DARYA KHAN05**

MASTER PLAN OF THQ HOSPITAL DARYA KHAN

PART 3

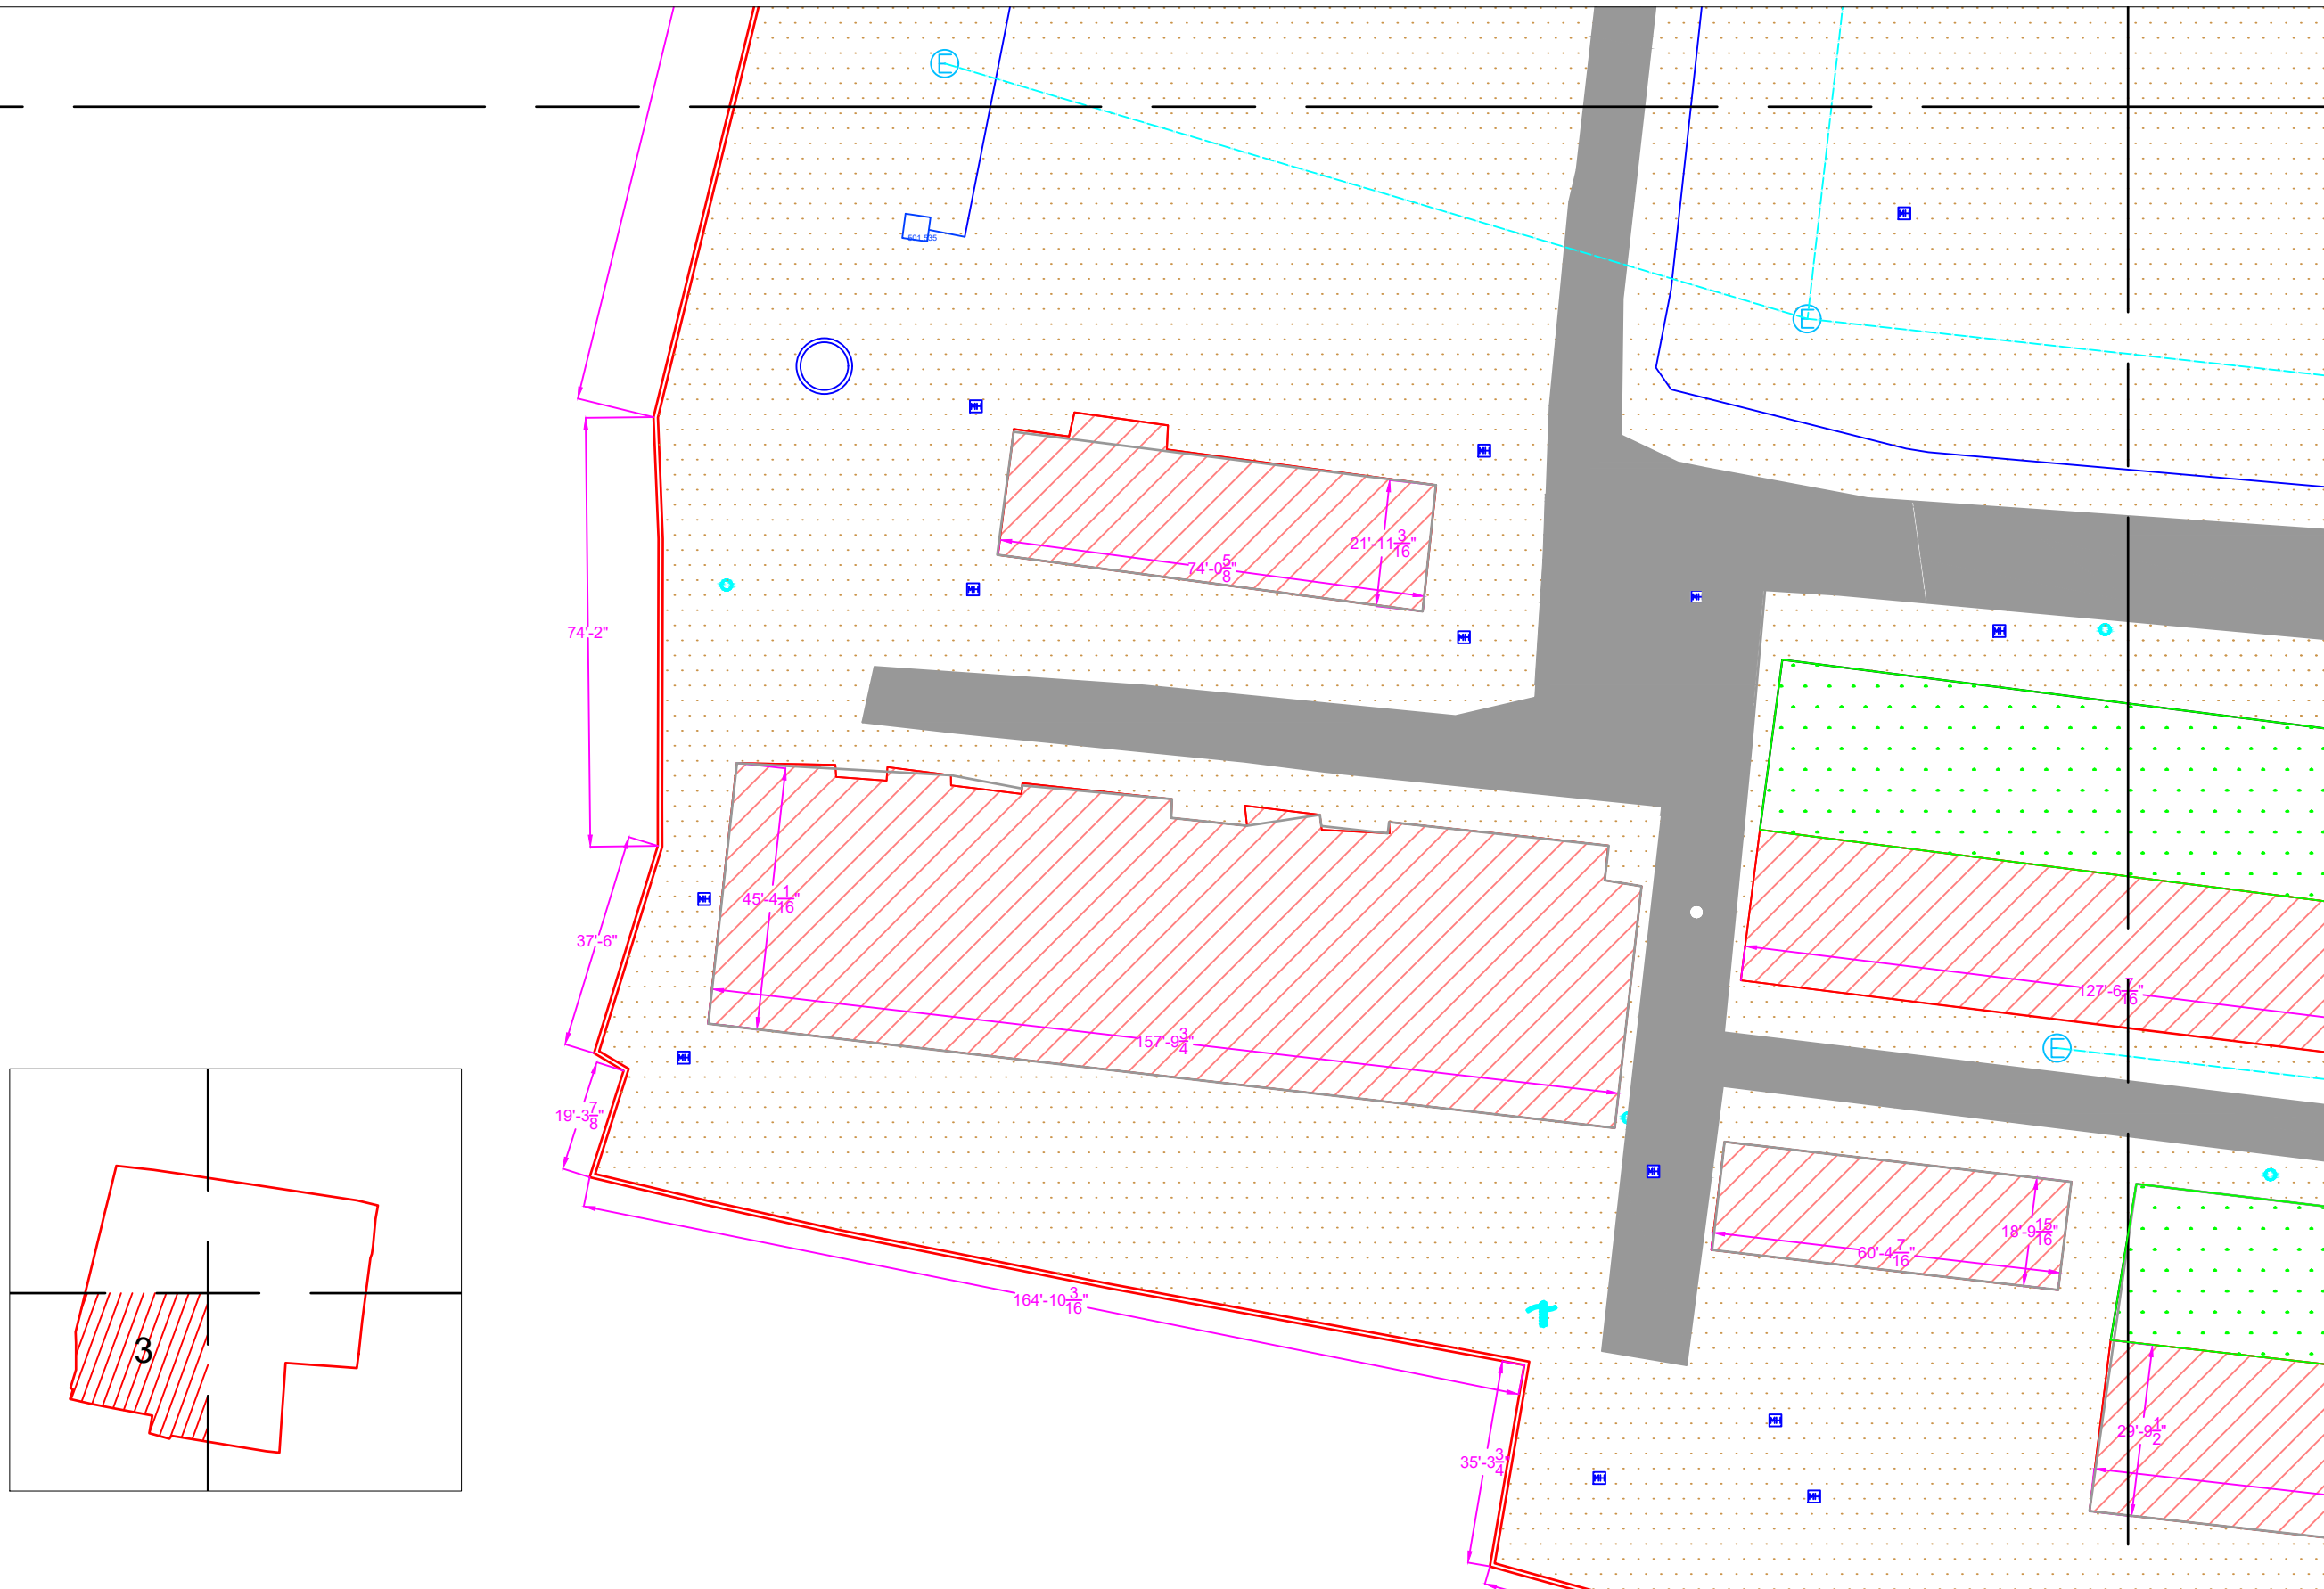

Legends:

Residential Area	
Road	
Wall	
Power Line	
OHT	
Tree	
Man Hole	
Tube Well	
Light Pole	
Lawns	
Earthen Areas	
Asphalts Roads	
Tough Pavers	
P.C.C / Plinth Protection	
Boundary Wall	
Brick Pavers / Soling	
Drain	
Tap	
Hand Pump	
Air Conditioner	
Tube Light	
Fan	
Roof Light	
Bulb	

AREA					
AREA WITHIN BOUNDARY WALL			245075.277 Sft		
AREA OF CLINICAL BLOCK			26851.4273 Sft		
PLINTH AREA OF BLOCK			3244.5719 Sft		

OPENING SCHEDULE OF DOORS AND WINDOWS					
DOORS	WIDTH	HEIGHT	WINDOWS	WIDTH	HEIGHT
D1	2'-0"	7'-0"	W1	3'-0"	5'-0"
D2	2'-6"	7'-0"	W2	4'-0"	4'-0"
D3	3'-0"	7'-0"	W3	6'-0"	6'-0"
D4	3'-6"	7'-0"	W4	8'-0"	8'-0"
D5	4'-0"	7'-0"	W5	5'-0"	5'-0"
D6	4'-6"	7'-0"	W6		
D7	5'-0"	7'-0"	W7		
D8	6'-0"	7'-0"	V1	2'-0"	2'-0"
D9	7'-0"	7'-0"	V2		

Project:

CAD MAPPING OF TEHSIL HEAD QUARTER HOSPITALS, PUNJAB

Client:

GOVERNMENT OF THE PUNJAB
PRIMARY & SECONDARY
HEALTHCARE DEPARTMENT

Consultant:

SKAFS CONSULTANT (Pvt.)
Limited
ENGINEERING AND ENVIRONMENT
CONSULTANT

Drawing Title:



**THQ DARYA KHAN
HOSPITAL MASTER PLAN PART 3**

Drawing No.

SKAFS/DARYA KHAN06

MASTER PLAN OF THQ HOSPITAL DARYA KHAN

PART 4

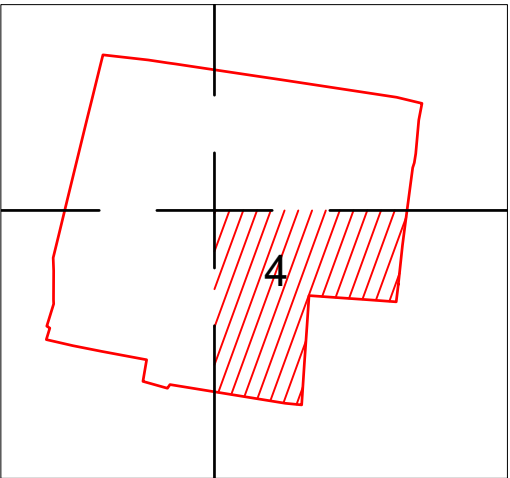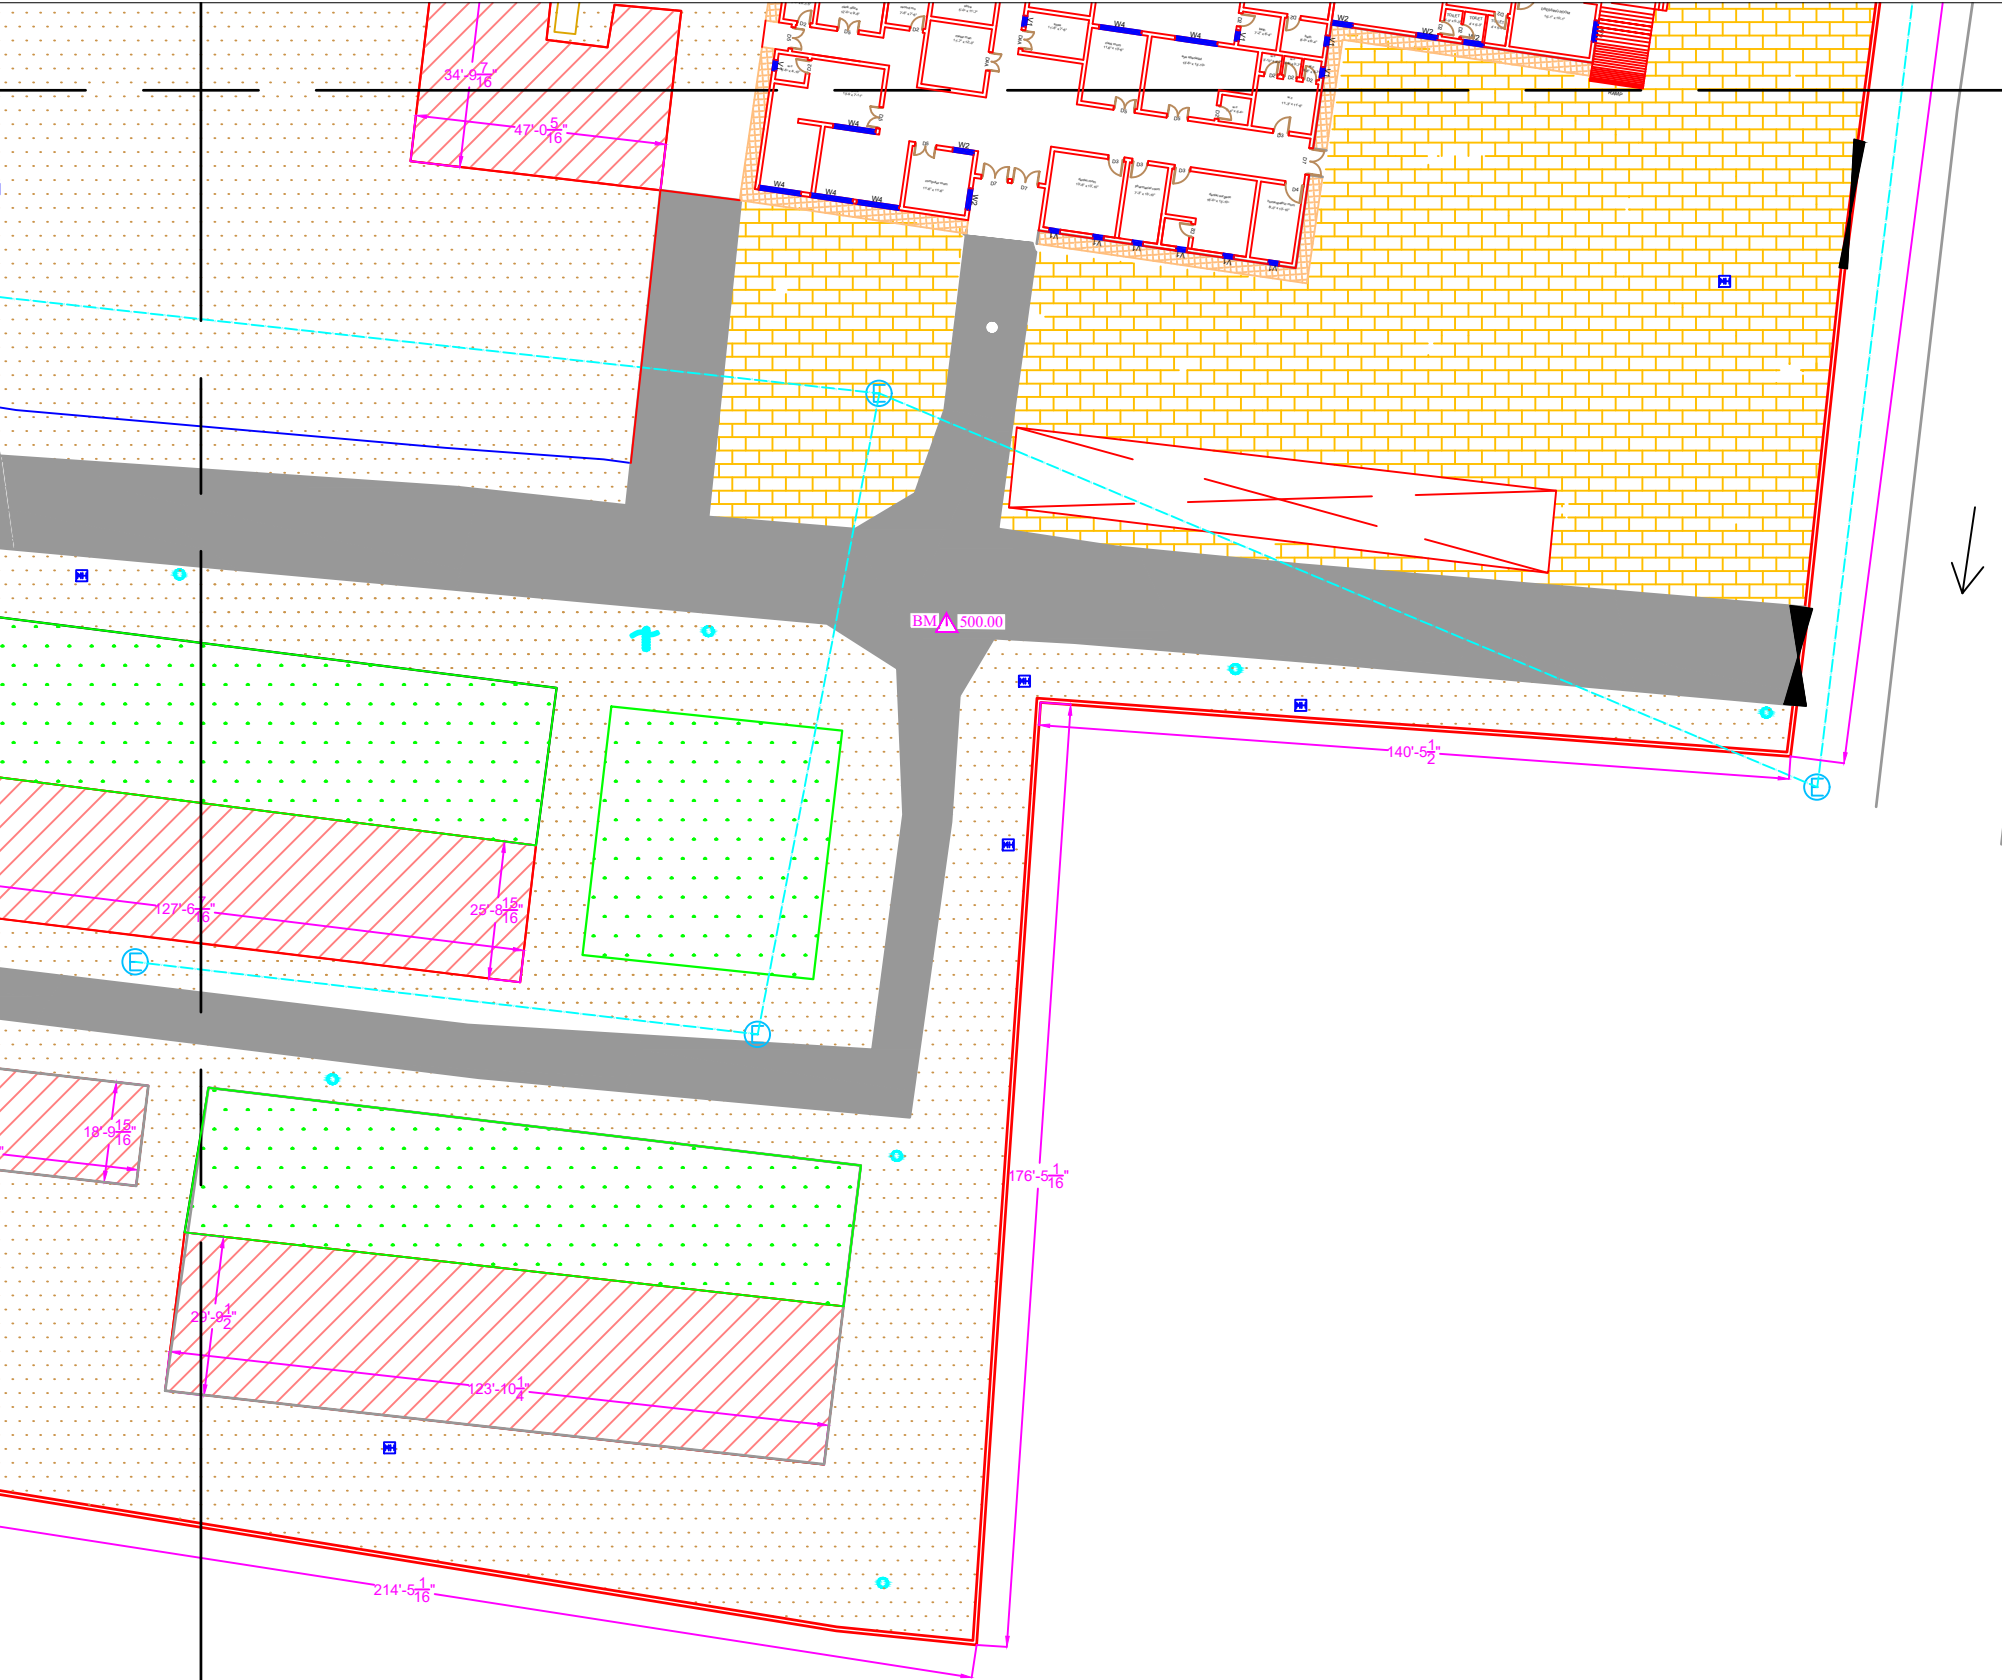

Legends:	
Residential Area	
Road	
Wall	
Power Line	
OHT	
Tree	
Man Hole	
Tube Well	
Light Pole	
Lawns	
Earthen Areas	
Asphalts Roads	
Tough Pavers	
P.C.C / Plinth Protection	
Boundary Wall	
Brick Pavers / Soling	
Drain	
Tap	
Hand Pump	
Air Conditioner	
Tube Light	
Fan	
Roof Light	
Bulb	

AREA	
AREA WITHIN BOUNDARY WALL	245075.277 Sft
AREA OF CLINICAL BLOCK	26851.4273 Sft
PLINTH AREA OF BLOCK	3244.5719 Sft

OPENING SCHEDULE OF DOORS AND WINDOWS					
DOORS	WIDTH	HEIGHT	WINDOWS	WIDTH	HEIGHT
D1	2'-0"	7'-0"	W1	3'-0"	5'-0"
D2	2'-6"	7'-0"	W2	4'-0"	4'-0"
D3	3'-0"	7'-0"	W3	6'-0"	6'-0"
D4	3'-6"	7'-0"	W4	8'-0"	8'-0"
D5	4'-0"	7'-0"	W5	5'-0"	5'-0"
D6	4'-6"	7'-0"	W6		
D7	5'-0"	7'-0"	W7		
D8	6'-0"	7'-0"	V1	2'-0"	2'-0"
D9	7'-0"	7'-0"	V2		

Project:
**CAD MAPPING OF TEHSIL
HEAD QUARTER HOSPITALS,
PUNJAB**

Client: GOVERNMENT OF THE PUNJAB PRIMARY & SECONDARY HEALTHCARE DEPARTMENT	Consultant: SKAFS CONSULTANT (Pvt.) Limited ENGINEERING AND ENVIRONMENT CONSULTANT
---	--


Drawing Title:
**THQ DARYA KHAN
HOSPITAL MASTER PLAN PART 4**

Drawing No.
SKAFS/DARYA KHAN07


CLINICAL BLOCK OF THQ HOSPITAL DARYA KHAN

GROUND FLOOR


PART 1

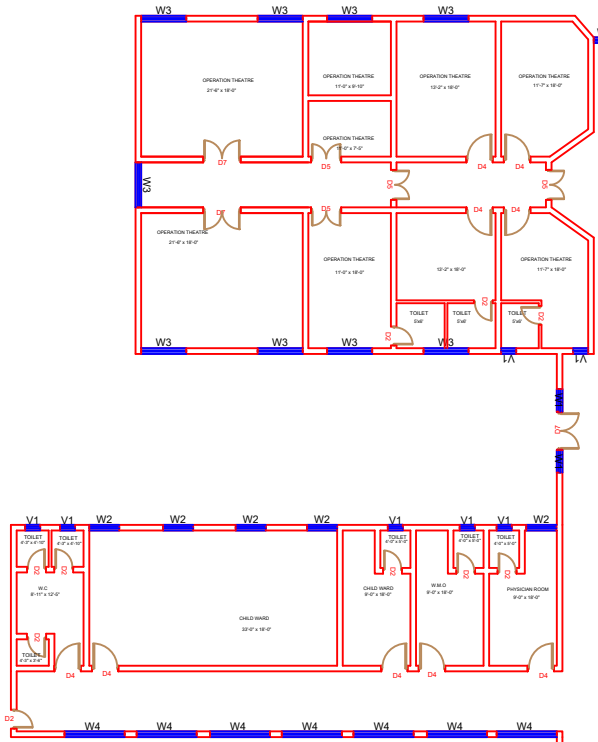


PART 3

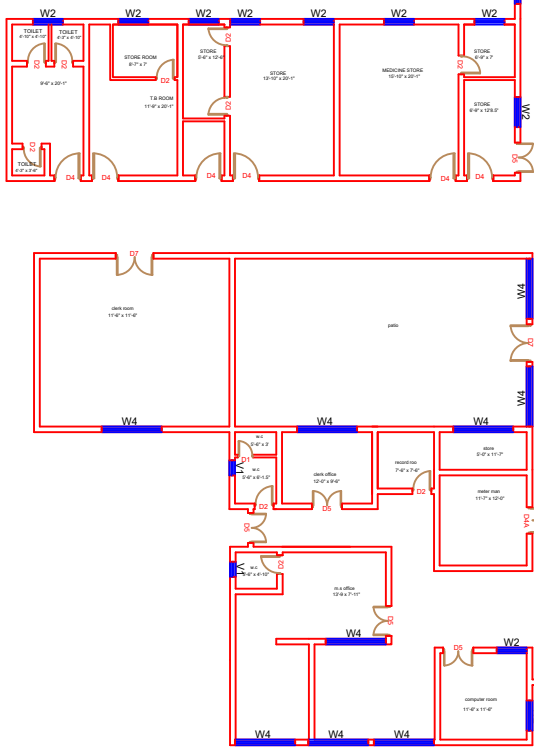

PART 2

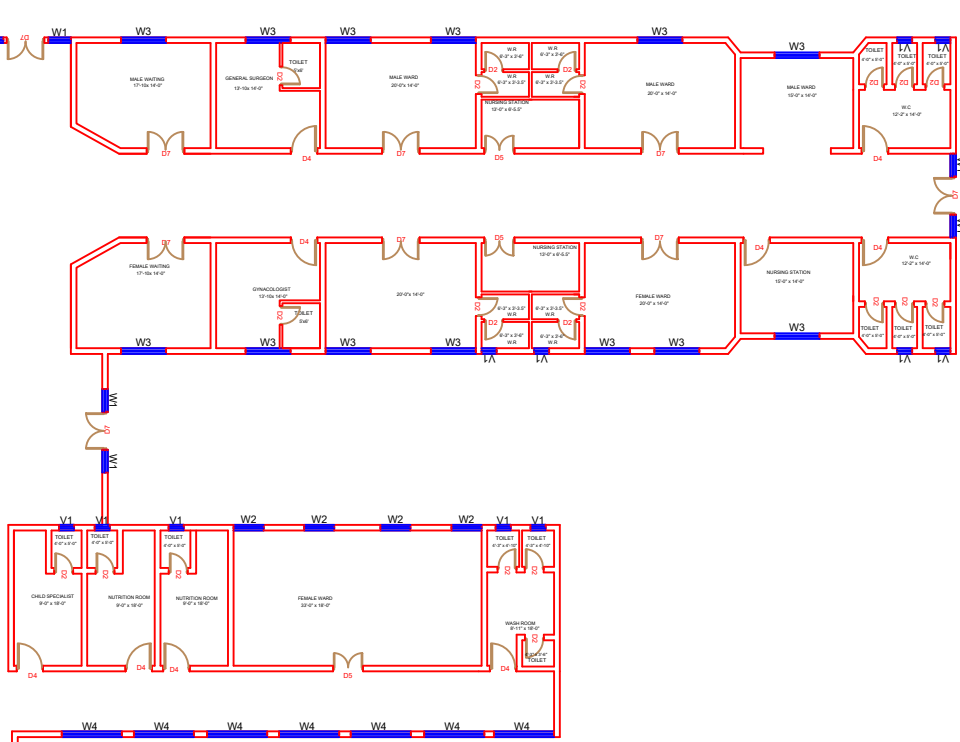

PART 4

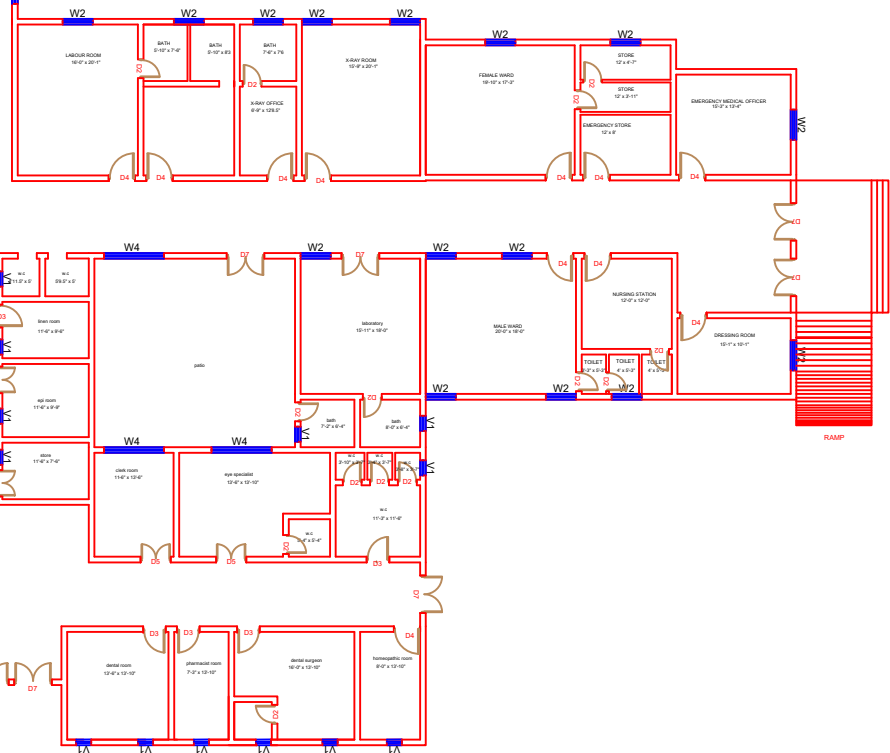

Legends:

Residential Area

Road

Wall

Power Line

OHT

Tree

Man Hole

Tube Well

Light Pole

Lawns

Earthen Areas

Asphalts Roads

Tough Pavers

P.C.C / Plinth Protection

Boundary Wall

Brick Pavers / Soling

Drain

Tap

Hand Pump

Air Conditioner

Tube Light

Fan

Roof Light

Bulb

AREA

AREA WITHIN BOUNDARY WALL

AREA OF CLINICAL BLOCK

PLINTH AREA OF BLOCK

245075.277 Sft

26851.4273 Sft

3244.5719 Sft

OPENING SCHEDULE OF DOORS AND WINDOWS

DOORS	WIDTH	HEIGHT	WINDOWS	WIDTH	HEIGHT
D1	2'-0"	7'-0"	W1	3'-0"	5'-0"
D2	2'-6"	7'-0"	W2	4'-0"	4'-0"
D3	3'-0"	7'-0"	W3	6'-0"	6'-0"
D4	3'-6"	7'-0"	W4	8'-0"	8'-0"
D5	4'-0"	7'-0"	W5	5'-0"	5'-0"
D6	4'-6"	7'-0"	W6		
D7	5'-0"	7'-0"	W7		
D8	6'-0"	7'-0"	V1	2'-0"	2'-0"
D9	7'-0"	7'-0"	V2		

Project:

CAD MAPPING OF TEHSIL HEAD QUARTER HOSPITALS, PUNJAB

Client:

GOVERNMENT OF THE PUNJAB
PRIMARY & SECONDARY
HEALTHCARE DEPARTMENT

Consultant:

SKAFS CONSULTANT (Pvt.)
Limited
ENGINEERING AND ENVIRONMENT
CONSULTANT

Drawing Title:

THQ DARYA KHAN
HOSPITAL CLINICAL BLOCK PLAN

Drawing No.

SKAFS/DARYA KHAN08

CLINICAL BLOCK OF THQ HOSPITAL DARYA KHAN

GROUND FLOOR PART 1



Legends:

Residential Area	
Road	
Wall	
Power Line	
OHT	
Tree	
Man Hole	
Tube Well	
Light Pole	
Lawns	
Earthen Areas	
Asphalts Roads	
Tough Pavers	
P.C.C / Plinth Protection	
Boundary Wall	
Brick Pavers / Soling	
Drain	
Tap	
Hand Pump	
Air Conditioner	
Tube Light	
Fan	
Roof Light	
Bulb	

AREA					
AREA WITHIN BOUNDARY WALL		245075.277 Sft			
AREA OF CLINICAL BLOCK		26851.4273 Sft			
PLINTH AREA OF BLOCK		3244.5719 Sft			

OPENING SCHEDULE OF DOORS AND WINDOWS					
DOORS	WIDTH	HEIGHT	WINDOWS	WIDTH	HEIGHT
D1	2'-0"	7'-0"	W1	3'-0"	5'-0"
D2	2'-6"	7'-0"	W2	4'-0"	4'-0"
D3	3'-0"	7'-0"	W3	6'-0"	6'-0"
D4	3'-6"	7'-0"	W4	8'-0"	8'-0"
D5	4'-0"	7'-0"	W5	5'-0"	5'-0"
D6	4'-6"	7'-0"	W6		
D7	5'-0"	7'-0"	W7		
D8	6'-0"	7'-0"	V1	2'-0"	2'-0"
D9	7'-0"	7'-0"	V2		

Project:
**CAD MAPPING OF TEHSIL
HEAD QUARTER HOSPITALS,
PUNJAB**


Client: GOVERNMENT OF THE PUNJAB PRIMARY & SECONDARY HEALTHCARE DEPARTMENT	Consultant: SKAFS CONSULTANT (Pvt.) Limited ENGINEERING AND ENVIRONMENT CONSULTANT
---	--

Drawing Title:
**THQ DARYA KHAN
CLINICAL BLOCK PLAN (PART 1)**

Drawing No.
SKAFS/DARYA KHAN09

CLINICAL BLOCK OF THQ HOSPITAL DARYA KHAN

GROUND FLOOR PART 2

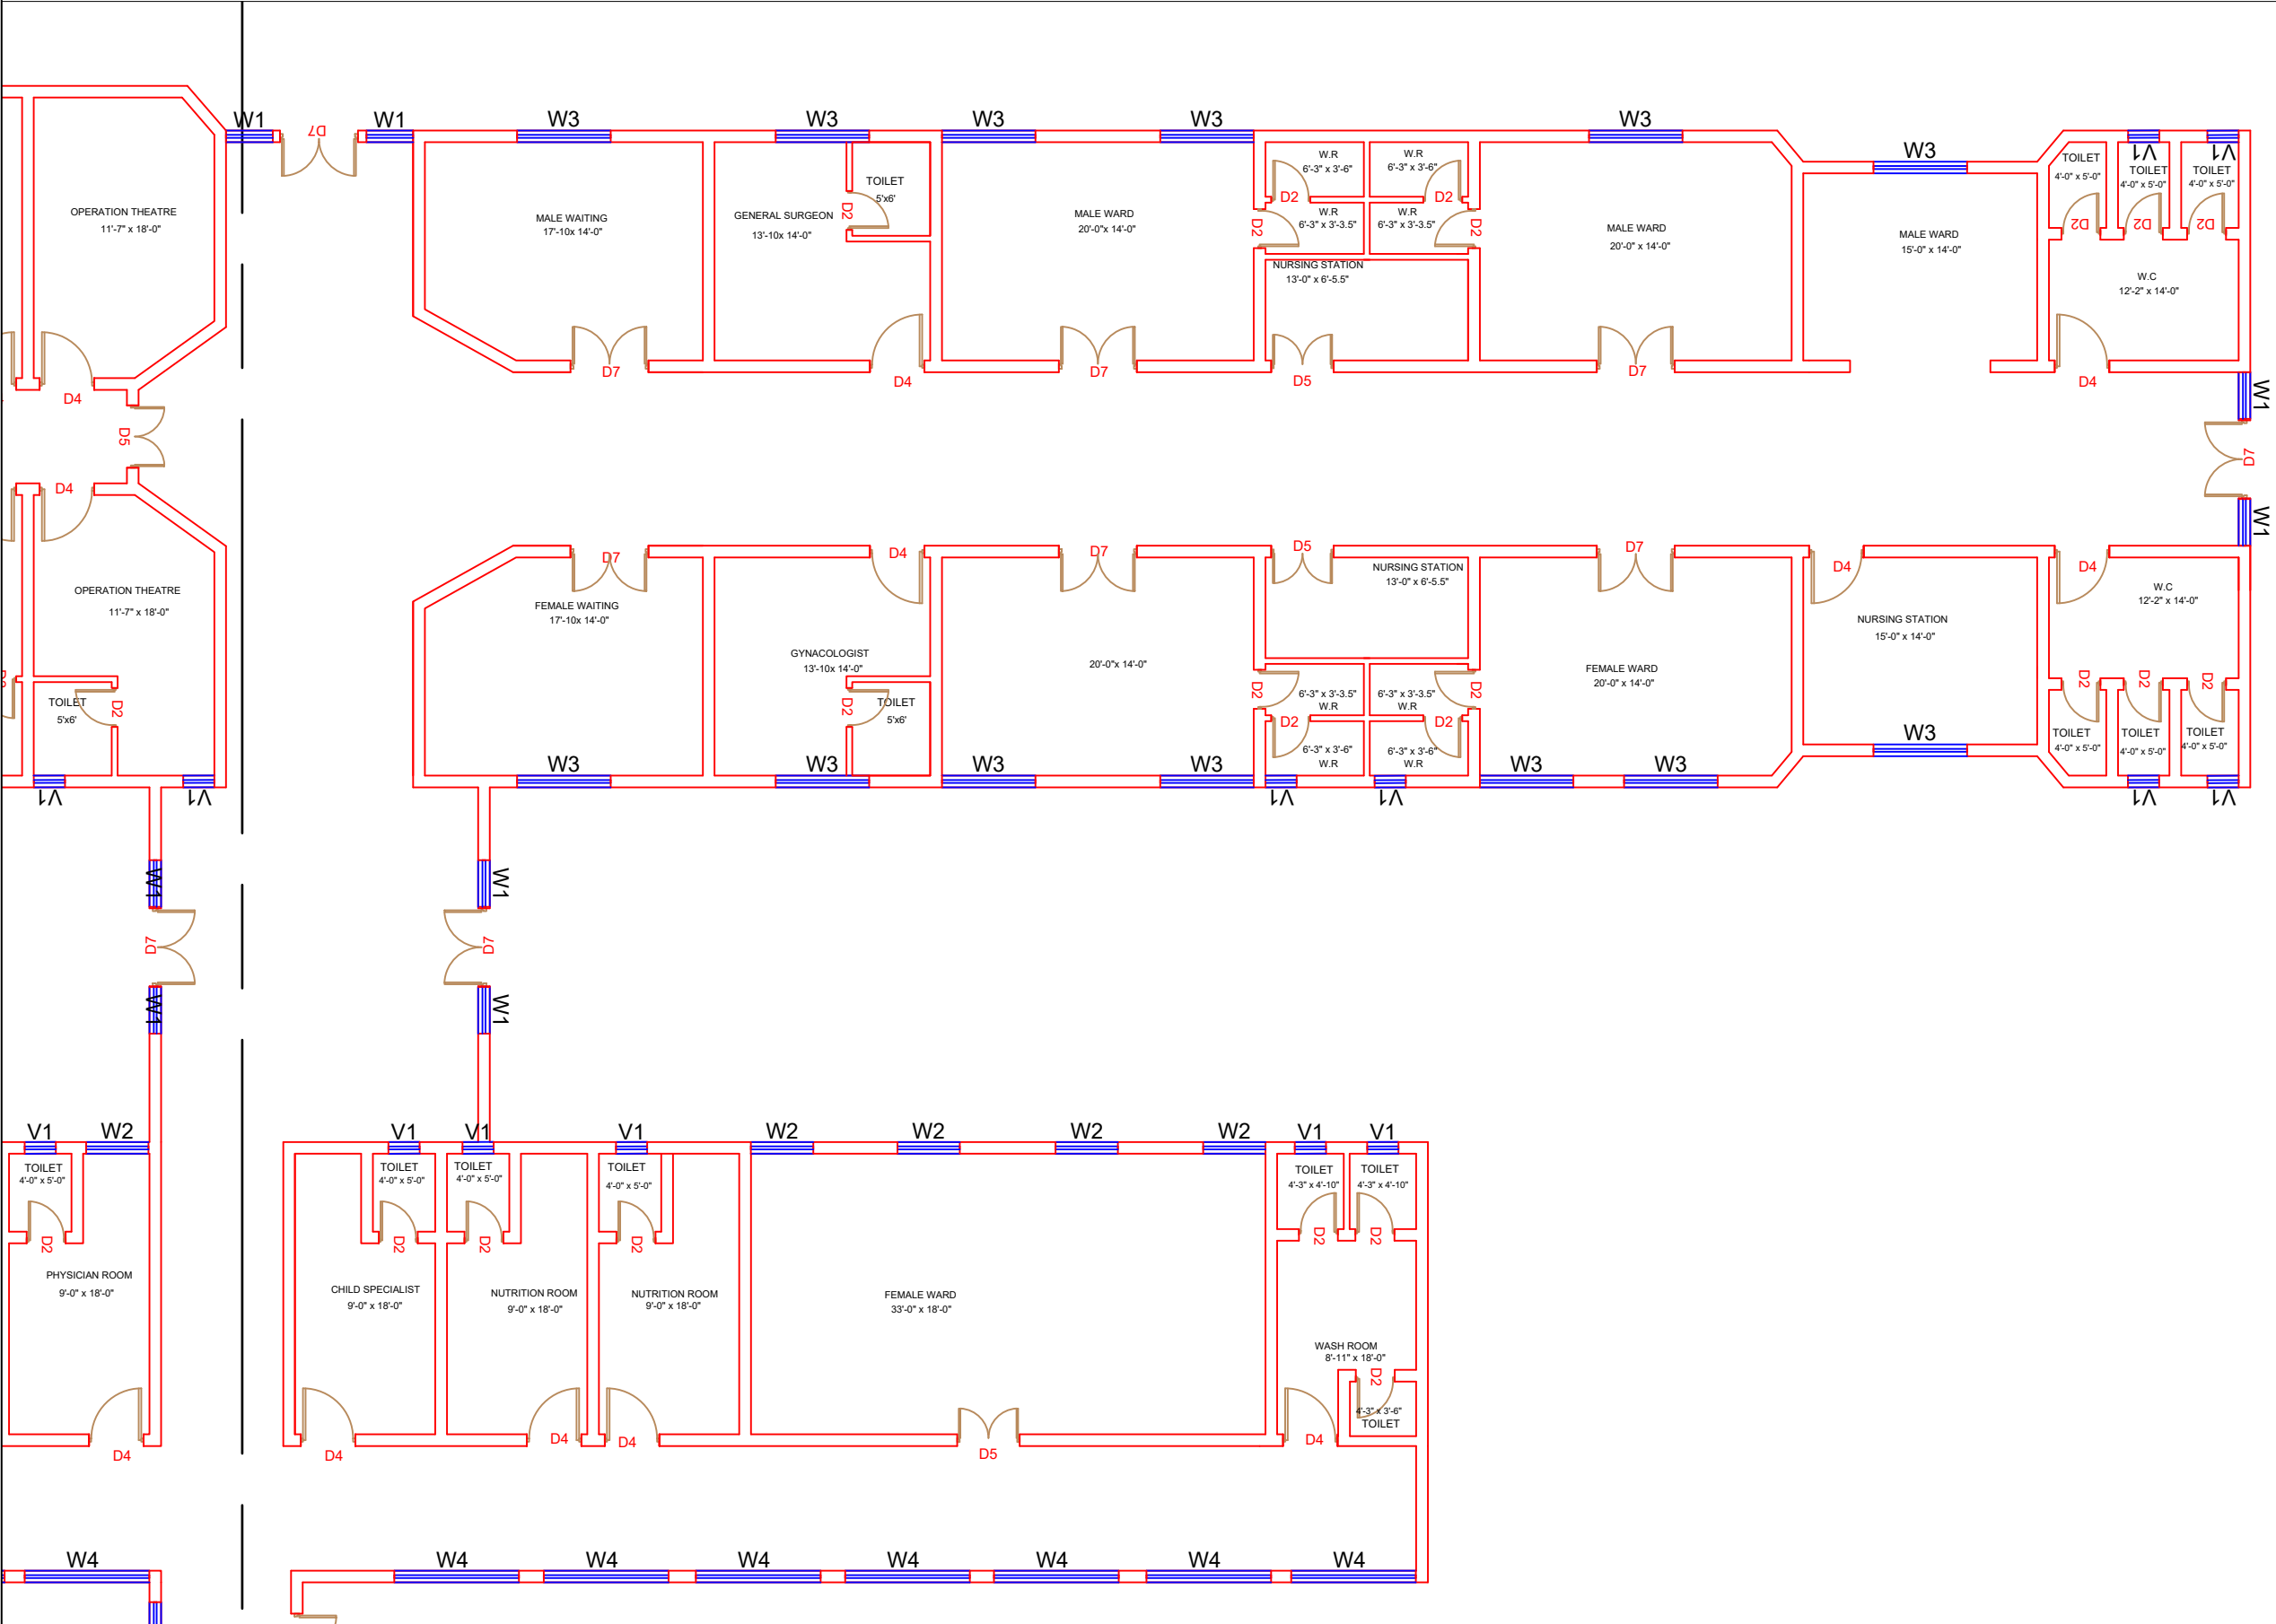

Legends:

Residential Area	
Road	
Wall	
Power Line	
OHT	
Tree	
Man Hole	
Tube Well	
Light Pole	
Lawns	
Earthen Areas	
Asphalts Roads	
Tough Pavers	
P.C.C / Plinth Protection	
Boundary Wall	
Brick Pavers / Soling	
Drain	
Tap	
Hand Pump	
Air Conditioner	
Tube Light	
Fan	
Roof Light	
Bulb	

AREA					
AREA WITHIN BOUNDARY WALL	245075.277 Sft				
AREA OF CLINICAL BLOCK	26851.4273 Sft				
PLINTH AREA OF BLOCK	3244.5719 Sft				

OPENING SCHEDULE OF DOORS AND WINDOWS					
DOORS	WIDTH	HEIGHT	WINDOWS	WIDTH	HEIGHT
D1	2'-0"	7'-0"	W1	3'-0"	5'-0"
D2	2'-6"	7'-0"	W2	4'-0"	4'-0"
D3	3'-0"	7'-0"	W3	6'-0"	6'-0"
D4	3'-6"	7'-0"	W4	8'-0"	8'-0"
D5	4'-0"	7'-0"	W5	5'-0"	5'-0"
D6	4'-6"	7'-0"	W6		
D7	5'-0"	7'-0"	W7		
D8	6'-0"	7'-0"	V1	2'-0"	2'-0"
D9	7'-0"	7'-0"	V2		

Project:
**CAD MAPPING OF TEHSIL
HEAD QUARTER HOSPITALS,
PUNJAB**


Client: GOVERNMENT OF THE PUNJAB PRIMARY & SECONDARY HEALTHCARE DEPARTMENT	Consultant: SKAFS CONSULTANT (Pvt.) Limited ENGINEERING AND ENVIRONMENT CONSULTANT
---	--

Drawing Title:
**THQ DARYA KHAN
CLINICAL BLOCK PLAN (PART 2)**

Drawing No.
SKAFS/DARYA KHAN/10

CLINICAL BLOCK OF THQ HOSPITAL DARYA KHAN

GROUND FLOOR PART 3

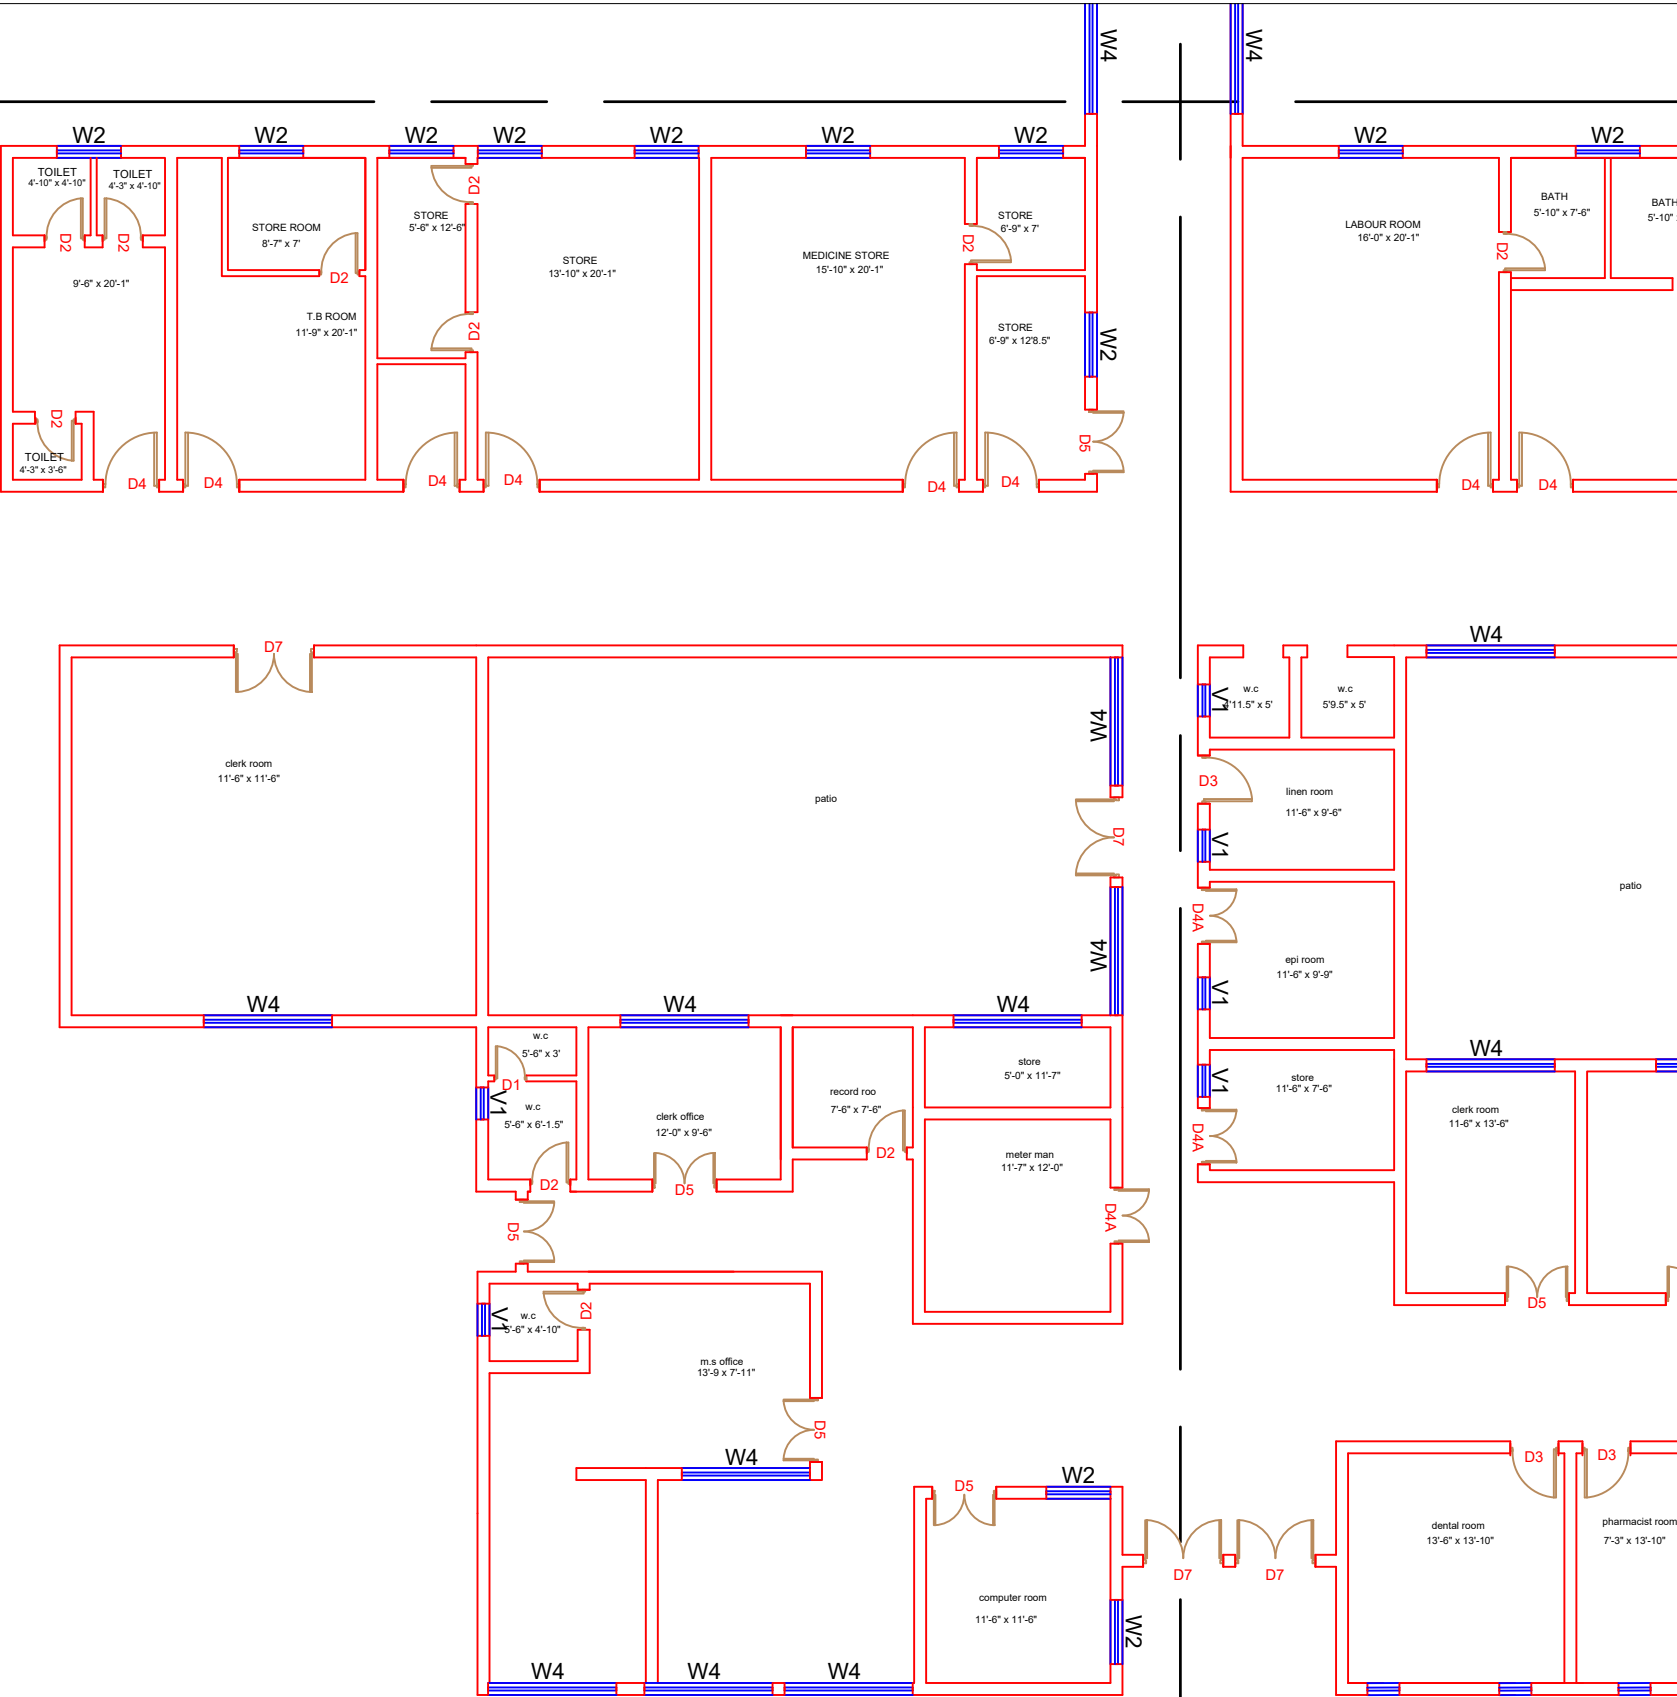

Legends:

Residential Area	
Road	
Wall	
Power Line	
OHT	
Tree	
Man Hole	
Tube Well	
Light Pole	
Lawns	
Earthen Areas	
Asphalts Roads	
Tough Pavers	
P.C.C / Plinth Protection	
Boundary Wall	
Brick Pavers / Soling	
Drain	
Tap	
Hand Pump	
Air Conditioner	
Tube Light	
Fan	
Roof Light	
Bulb	

AREA	
AREA WITHIN BOUNDARY WALL	245075.277 Sft
AREA OF CLINICAL BLOCK	26851.4273 Sft
PLINTH AREA OF BLOCK	3244.5719 Sft

OPENING SCHEDULE OF DOORS AND WINDOWS					
DOORS	WIDTH	HEIGHT	WINDOWS	WIDTH	HEIGHT
D1	2'-0"	7'-0"	W1	3'-0"	5'-0"
D2	2'-6"	7'-0"	W2	4'-0"	4'-0"
D3	3'-0"	7'-0"	W3	6'-0"	6'-0"
D4	3'-6"	7'-0"	W4	8'-0"	8'-0"
D5	4'-0"	7'-0"	W5	5'-0"	5'-0"
D6	4'-6"	7'-0"	W6		
D7	5'-0"	7'-0"	W7		
D8	6'-0"	7'-0"	V1	2'-0"	2'-0"
D9	7'-0"	7'-0"	V2		

Project: CAD MAPPING OF TEHSIL HEAD QUARTER HOSPITALS, PUNJAB


Client:	Consultant:
GOVERNMENT OF THE PUNJAB PRIMARY & SECONDARY HEALTHCARE DEPARTMENT	SKAFS CONSULTANT (Pvt.) Limited ENGINEERING AND ENVIRONMENT CONSULTANT

Drawing Title: THQ DARYA KHAN CLINICAL BLOCK PLAN (PART 3)

Drawing No. SKAFS/DARYA KHAN/11

CLINICAL BLOCK OF THQ HOSPITAL DARYA KHAN

GROUND FLOOR PART 4

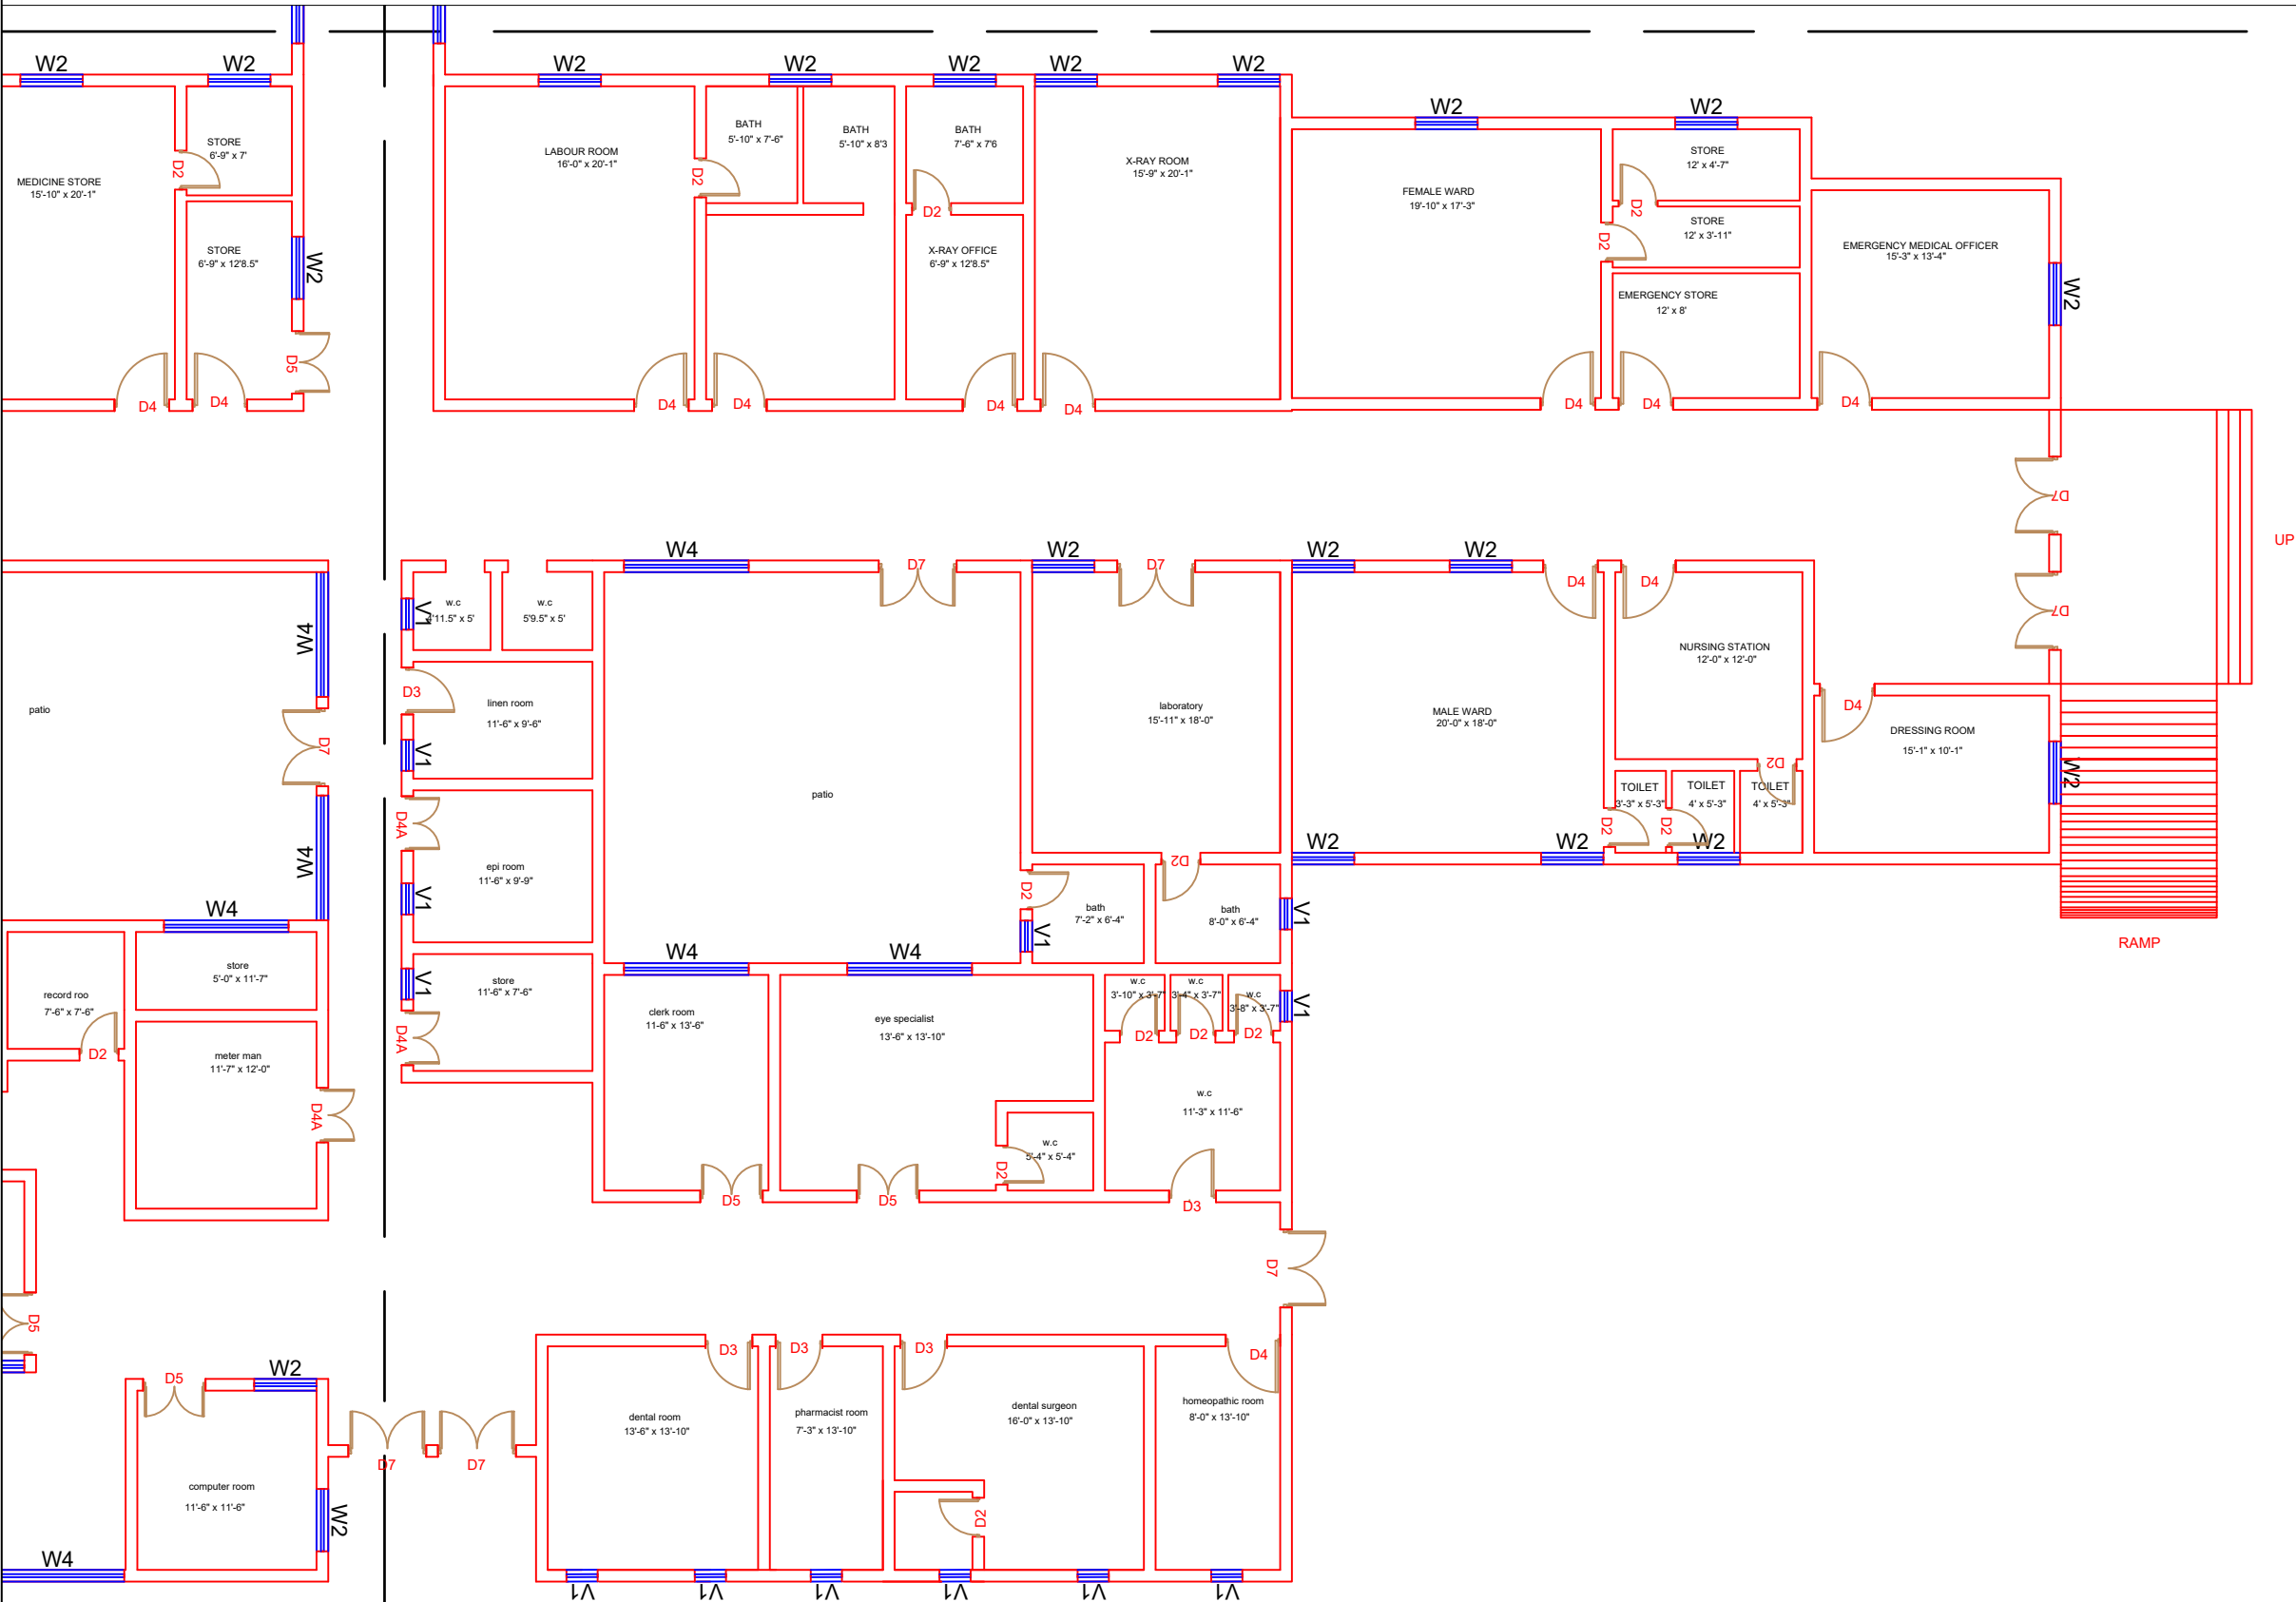

Legends:

Residential Area	
Road	
Wall	
Power Line	
OHT	
Tree	
Man Hole	
Tube Well	
Light Pole	
Lawns	
Earthen Areas	
Asphalts Roads	
Tough Pavers	
P.C.C / Plinth Protection	
Boundary Wall	
Brick Pavers / Soling	
Drain	
Tap	
Hand Pump	
Air Conditioner	
Tube Light	
Fan	
Roof Light	
Bulb	

AREA	
AREA WITHIN BOUNDARY WALL	245075.277 Sft
AREA OF CLINICAL BLOCK	26851.4273 Sft
PLINTH AREA OF BLOCK	3244.5719 Sft

OPENING SCHEDULE OF DOORS AND WINDOWS					
DOORS	WIDTH	HEIGHT	WINDOWS	WIDTH	HEIGHT
D1	2'-0"	7'-0"	W1	3'-0"	5'-0"
D2	2'-6"	7'-0"	W2	4'-0"	4'-0"
D3	3'-0"	7'-0"	W3	6'-0"	6'-0"
D4	3'-6"	7'-0"	W4	8'-0"	8'-0"
D5	4'-0"	7'-0"	W5	5'-0"	5'-0"
D6	4'-6"	7'-0"	W6		
D7	5'-0"	7'-0"	W7		
D8	6'-0"	7'-0"	V1	2'-0"	2'-0"
D9	7'-0"	7'-0"	V2		

Project:

CAD MAPPING OF TEHSIL HEAD QUARTER HOSPITALS, PUNJAB

Client:	Consultant:
 GOVERNMENT OF THE PUNJAB PRIMARY & SECONDARY HEALTHCARE DEPARTMENT	 SKAFS CONSULTANT (Pvt.) Limited ENGINEERING AND ENVIRONMENT CONSULTANT


Drawing Title:

**THQ DARYA KHAN
CLINICAL BLOCK PLAN (PART 4)**


Drawing No.

SKAFS/DARYA KHAN/12

ELECTRICAL LAYOUT PLAN OF THQ HOSPITAL DARYA KHAN GROUND FLOOR

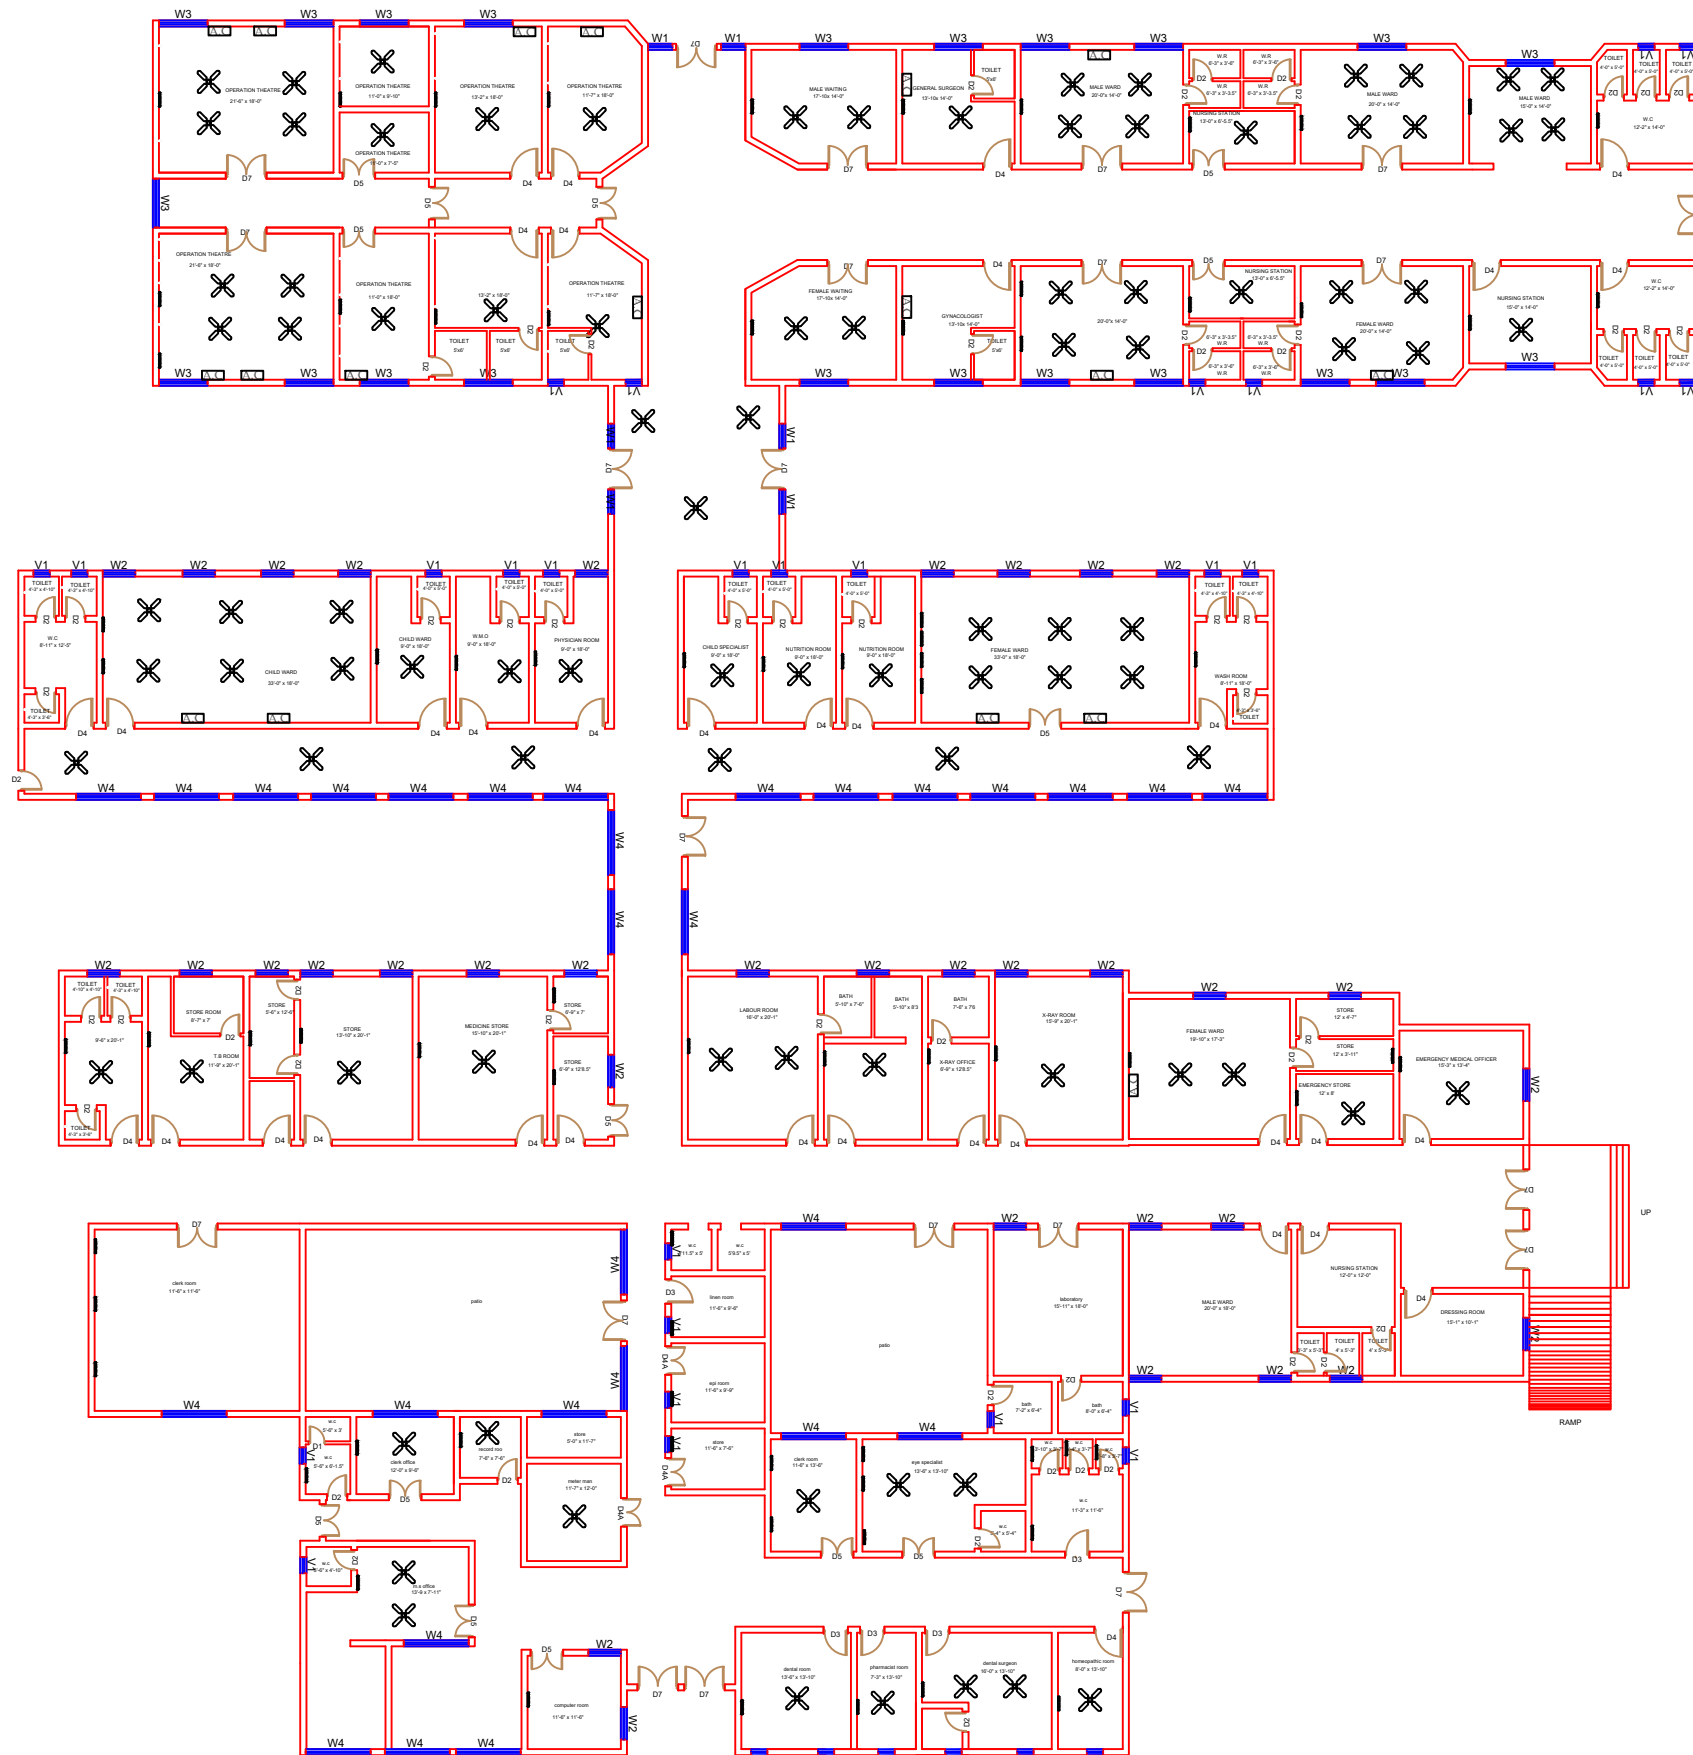

Legends:

 Residential Area	
Road	
Wall	
Power Line	
OHT	
Tree	
Man Hole	
Tube Well	
Light Pole	
Lawns	
Earthen Areas	
Asphalts Roads	
Tough Pavers	
P.C.C / Plinth Protection	
Boundary Wall	
Brick Pavers / Soling	
Drain	
Tap	
Hand Pump	
Air Conditioner	
Tube Light	
Fan	
Roof Light	
Bulb	

AREA	
AREA WITHIN BOUNDARY WALL	245075.277 Sft
AREA OF CLINICAL BLOCK	26851.4273 Sft
PLINTH AREA OF BLOCK	3244.5719 Sft

OPENING SCHEDULE OF DOORS AND WINDOWS					
DOORS	WIDTH	HEIGHT	WINDOWS	WIDTH	HEIGHT
D1	2'-0"	7'-0"	W1	3'-0"	5'-0"
D2	2'-6"	7'-0"	W2	4'-0"	4'-0"
D3	3'-0"	7'-0"	W3	6'-0"	6'-0"
D4	3'-6"	7'-0"	W4	8'-0"	8'-0"
D5	4'-0"	7'-0"	W5	5'-0"	5'-0"
D6	4'-6"	7'-0"	W6		
D7	5'-0"	7'-0"	W7		
D8	6'-0"	7'-0"	V1	2'-0"	2'-0"
D9	7'-0"	7'-0"	V2		

Project:
**CAD MAPPING OF TEHSIL
HEAD QUARTER HOSPITALS,
PUNJAB**

Client:  GOVERNMENT OF THE PUNJAB PRIMARY & SECONDARY HEALTHCARE DEPARTMENT	Consultant:  SKAFS CONSULTANT (Pvt.) Limited <i>ENGINEERING AND ENVIRONMENT CONSULTANT</i>
--	---

Drawing Title:	THQ DARYA KHAN ELECTRICAL PLAN (GROUND FLOOR)
----------------	--

Drawing No.	SKAFS/DARYA KHAN/13
-------------	----------------------------