


MASTER PLAN OF THQ HOSPITAL FATEH JANG

PART 1

PART 2

PART 3

PART 4

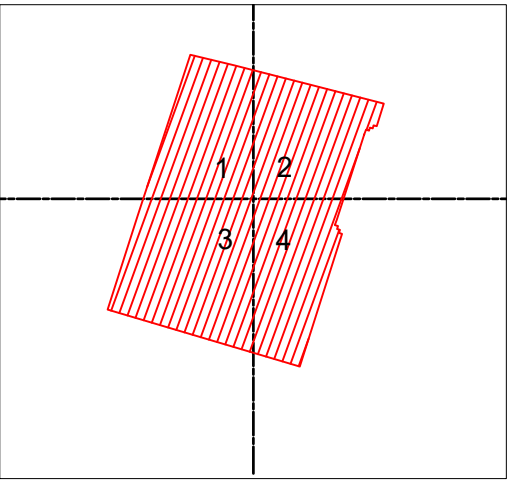

Legends:	
Residential Area	
Road	
Wall	
Power Line	
OHT	
Tree	
Man Hole	
Tube Well	
Light Pole	
Lawns	
Earthen Areas	
Asphalts Roads	
Tough Pavers	
P.C.C / Plinth Protection	
Boundary Wall	
Brick Pavers / Soling	
Drain	
Tap	
Hand Pump	
Air Conditioner	
Tube Light	
Fan	
Roof Light	
Bulb	

AREA	
AREA WITHIN BOUNDARY WALL	321750.5 Sft
AREA OF CLINICAL BLOCK	21811.12 Sft
PLINTH AREA OF BLOCK	21811.12 Sft

OPENING SCHEDULE OF DOORS AND WINDOWS					
DOORS	WIDTH	HEIGHT	WINDOWS	WIDTH	HEIGHT
D1	2'-0"	7'-0"	W1	3'-0"	5'-0"
D2	2'-6"	7'-0"	W2	4'-0"	4'-0"
D3	3'-0"	7'-0"	W3	6'-0"	6'-0"
D4	3'-6"	7'-0"	W4	8'-0"	8'-0"
D5	4'-0"	7'-0"	W5	5'-0"	5'-0"
D6	4'-6"	7'-0"	W6		
D7	5'-0"	7'-0"	W7		
D8	6'-0"	7'-0"	V1	2'-0"	2'-0"
D9	7'-0"	7'-0"	V2		

Project:
**CAD MAPPING OF TEHSIL
HEAD QUARTER HOSPITALS,
PUNJAB**


Client: GOVERNMENT OF THE PUNJAB PRIMARY & SECONDARY HEALTHCARE DEPARTMENT	Consultant: SKAFS CONSULTANT (Pvt.) Limited ENGINEERING AND ENVIRONMENT CONSULTANT
---	--

Drawing Title:
**THQ FATEH JANG
HOSPITAL MASTER PLAN**

Drawing No.
SKAFS/FATEH.J /03

MASTER PLAN OF THQ HOSPITAL FATEH JANG

PART 1

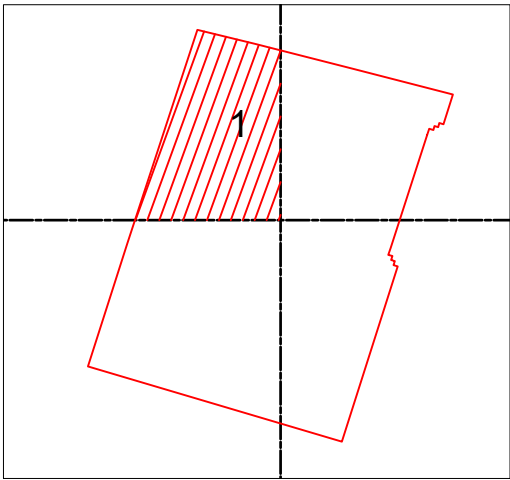

Legends:	
Residential Area	
Road	
Wall	
Power Line	
OHT	
Tree	
Man Hole	
Tube Well	
Light Pole	
Lawns	
Earthen Areas	
Asphalts Roads	
Tough Pavers	
P.C.C / Plinth Protection	
Boundary Wall	
Brick Pavers / Soling	
Drain	
Tap	
Hand Pump	
Air Conditioner	
Tube Light	
Fan	
Roof Light	
Bulb	



AREA	
AREA WITHIN BOUNDARY WALL	321750.5 Sft
AREA OF CLINICAL BLOCK	21811.12 Sft
PLINTH AREA OF BLOCK	21811.12 Sft

OPENING SCHEDULE OF DOORS AND WINDOWS					
DOORS	WIDTH	HEIGHT	WINDOWS	WIDTH	HEIGHT
D1	2'-0"	7'-0"	W1	3'-0"	5'-0"
D2	2'-6"	7'-0"	W2	4'-0"	4'-0"
D3	3'-0"	7'-0"	W3	6'-0"	6'-0"
D4	3'-6"	7'-0"	W4	8'-0"	8'-0"
D5	4'-0"	7'-0"	W5	5'-0"	5'-0"
D6	4'-6"	7'-0"	W6		
D7	5'-0"	7'-0"	W7		
D8	6'-0"	7'-0"	V1	2'-0"	2'-0"
D9	7'-0"	7'-0"	V2		

Project:	
CAD MAPPING OF TEHSIL HEAD QUARTER HOSPITALS, PUNJAB	
Client:	Consultant:
 GOVERNMENT OF THE PUNJAB PRIMARY & SECONDARY HEALTHCARE DEPARTMENT	 SKAFS CONSULTANT (Pvt.) Limited ENGINEERING AND ENVIRONMENT CONSULTANT
Drawing Title:	
THQ FATEH JANG HOSPITAL MASTER PLAN PART 1	
Drawing No.	
SKAFS/FATEH.J /04	

MASTER PLAN OF THQ HOSPITAL FATEH JANG

PART 2

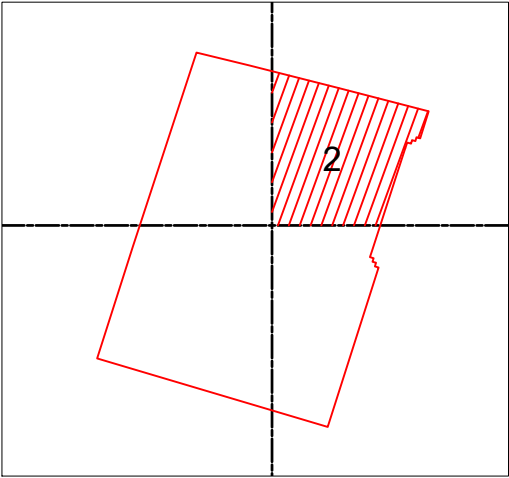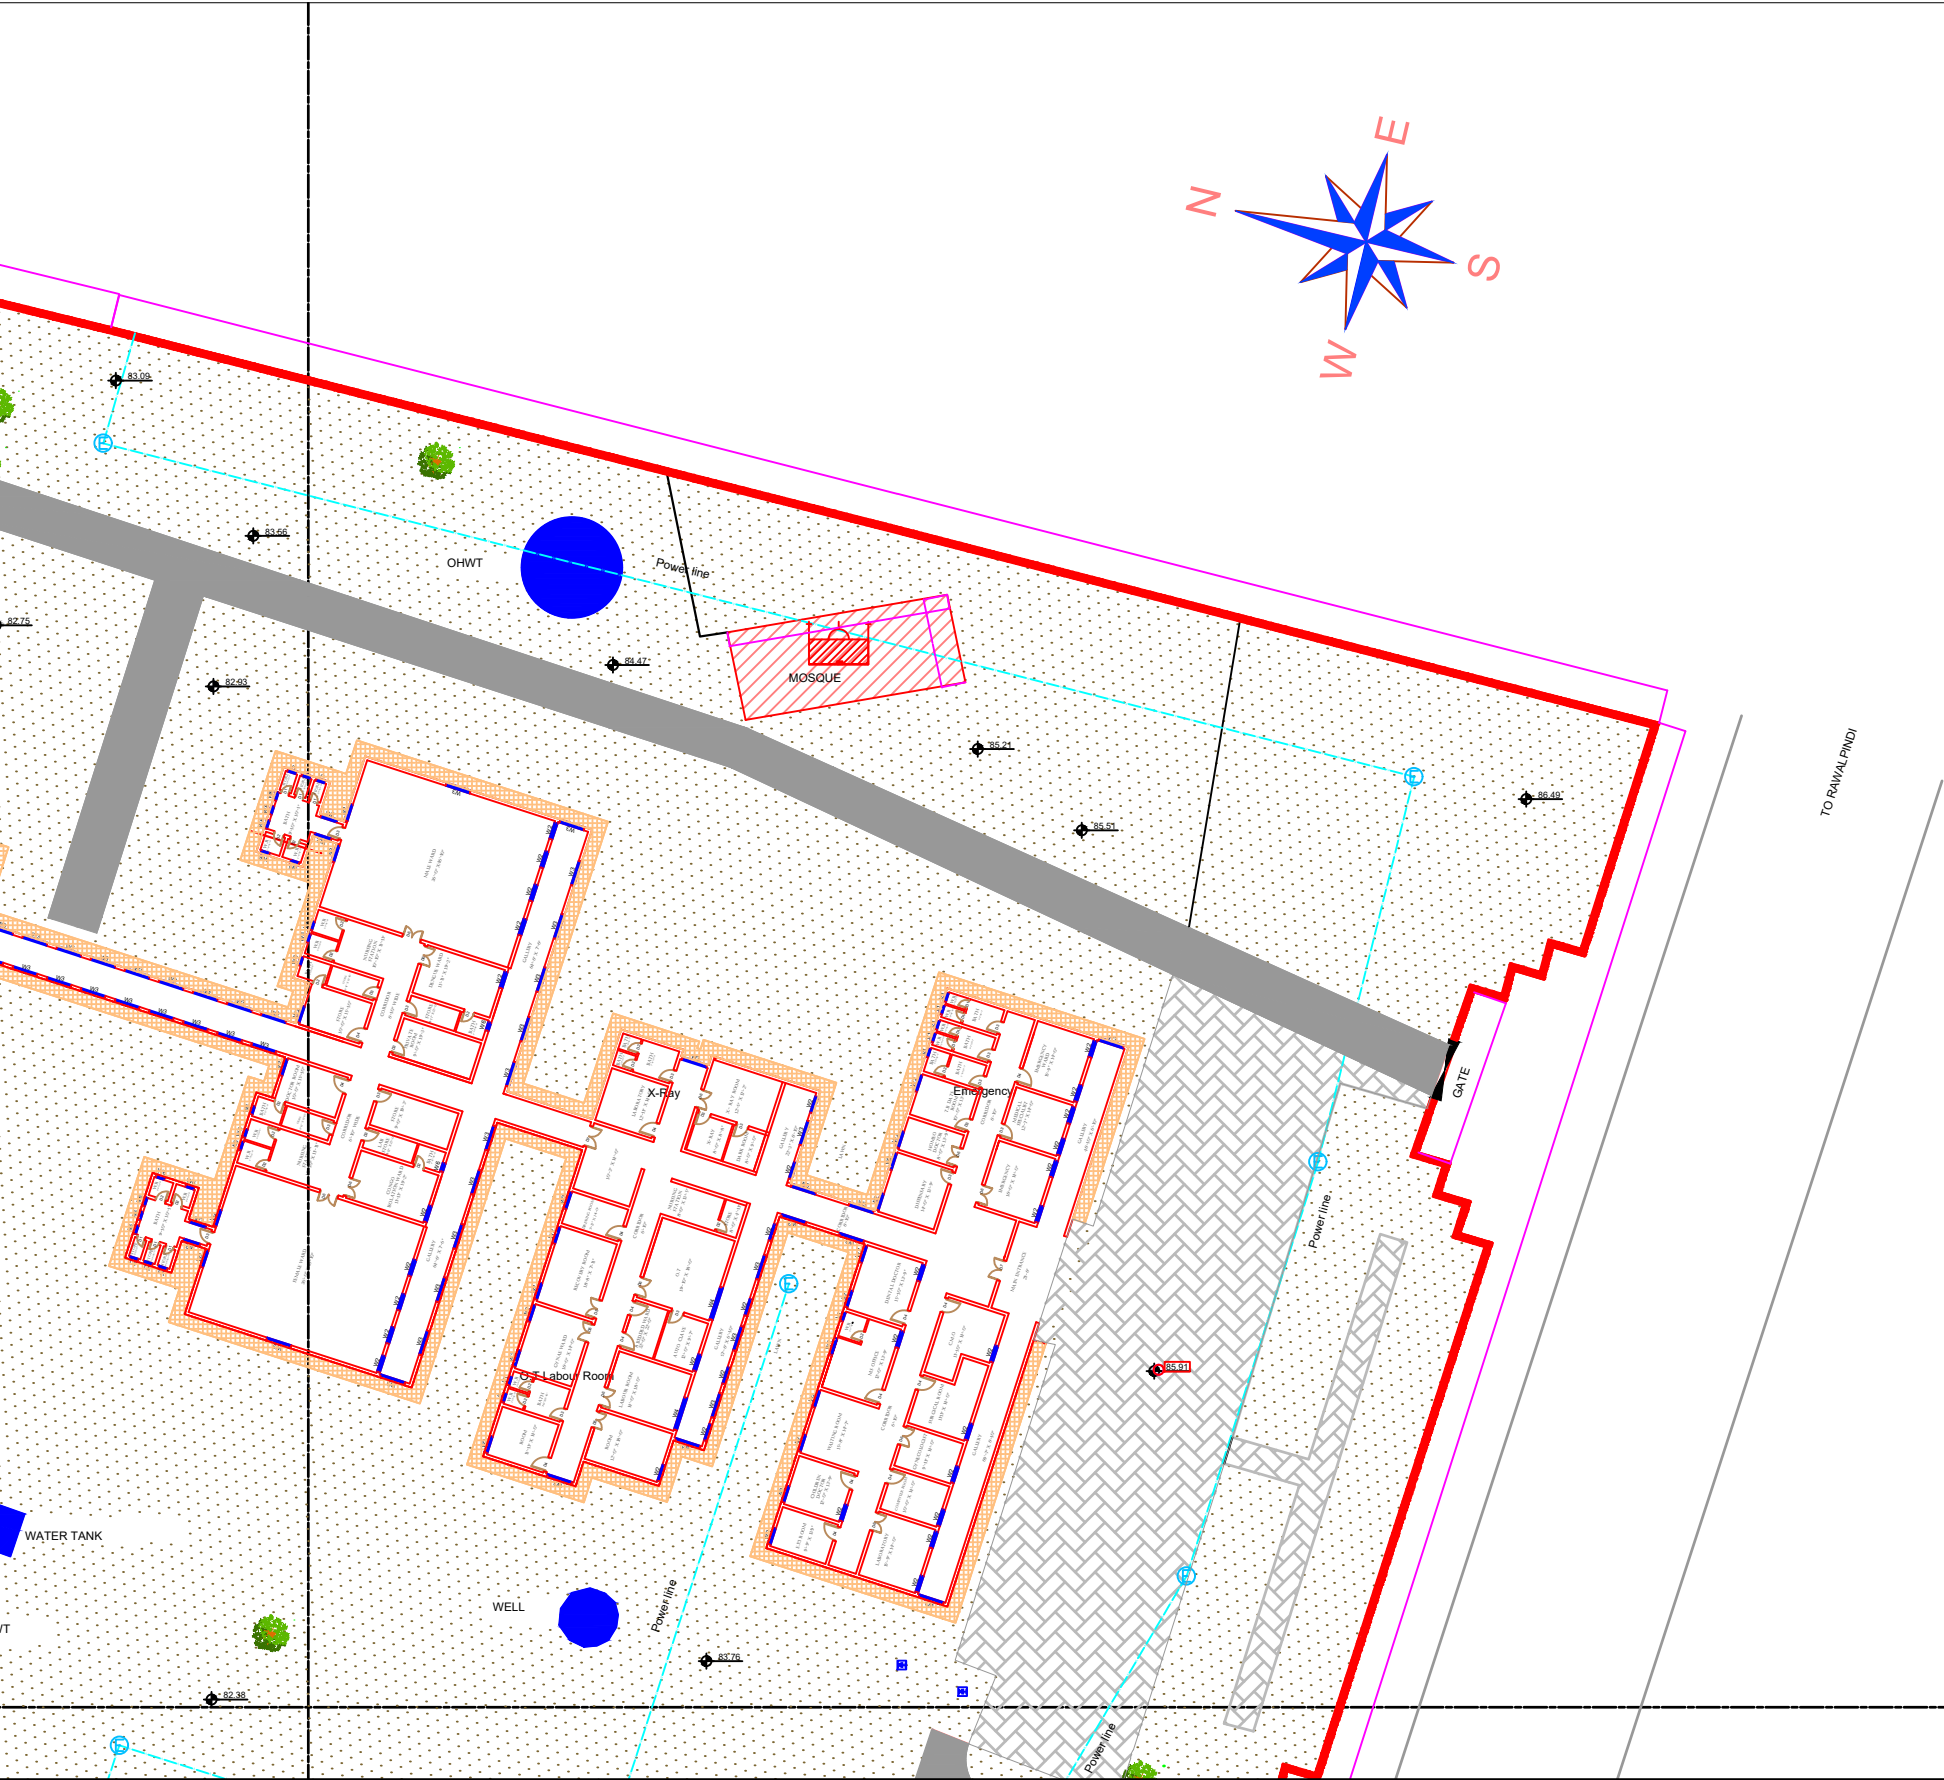

Legends:

Residential Area	
Road	
Wall	
Power Line	
OHT	
Tree	
Man Hole	
Tube Well	
Light Pole	
Lawns	
Earthen Areas	
Asphalts Roads	
Tough Pavers	
P.C.C / Plinth Protection	
Boundary Wall	
Brick Pavers / Soling	
Drain	
Tap	
Hand Pump	
Air Conditioner	
Tube Light	
Fan	
Roof Light	
Bulb	

AREA					
AREA WITHIN BOUNDARY WALL		321750.5 Sft			
AREA OF CLINICAL BLOCK		21811.12 Sft			
PLINTH AREA OF BLOCK		21811.12 Sft			

OPENING SCHEDULE OF DOORS AND WINDOWS					
DOORS	WIDTH	HEIGHT	WINDOWS	WIDTH	HEIGHT
D1	2'-0"	7'-0"	W1	3'-0"	5'-0"
D2	2'-6"	7'-0"	W2	4'-0"	4'-0"
D3	3'-0"	7'-0"	W3	6'-0"	6'-0"
D4	3'-6"	7'-0"	W4	8'-0"	8'-0"
D5	4'-0"	7'-0"	W5	5'-0"	5'-0"
D6	4'-6"	7'-0"	W6		
D7	5'-0"	7'-0"	W7		
D8	6'-0"	7'-0"	V1	2'-0"	2'-0"
D9	7'-0"	7'-0"	V2		

Project:

CAD MAPPING OF TEHSIL HEAD QUARTER HOSPITALS, PUNJAB

Client:	Consultant:
 GOVERNMENT OF THE PUNJAB PRIMARY & SECONDARY HEALTHCARE DEPARTMENT	 SKAFS CONSULTANT (Pvt.) Limited ENGINEERING AND ENVIRONMENT CONSULTANT

Drawing Title:



**THQ FATEH JANG
HOSPITAL MASTER PLAN PART 2**

Drawing No.

SKAFS/FATEH.J /05

MASTER PLAN OF THQ HOSPITAL FATEH JANG

PART 3

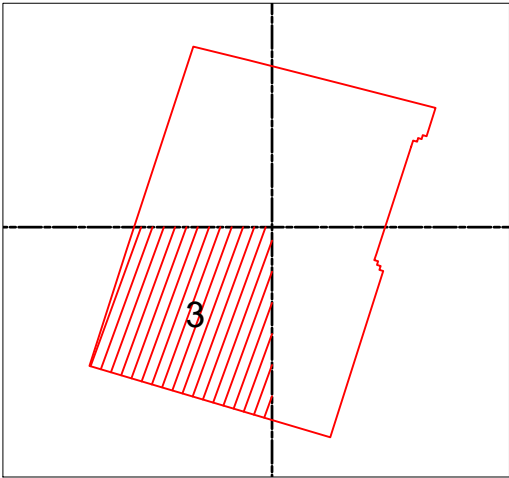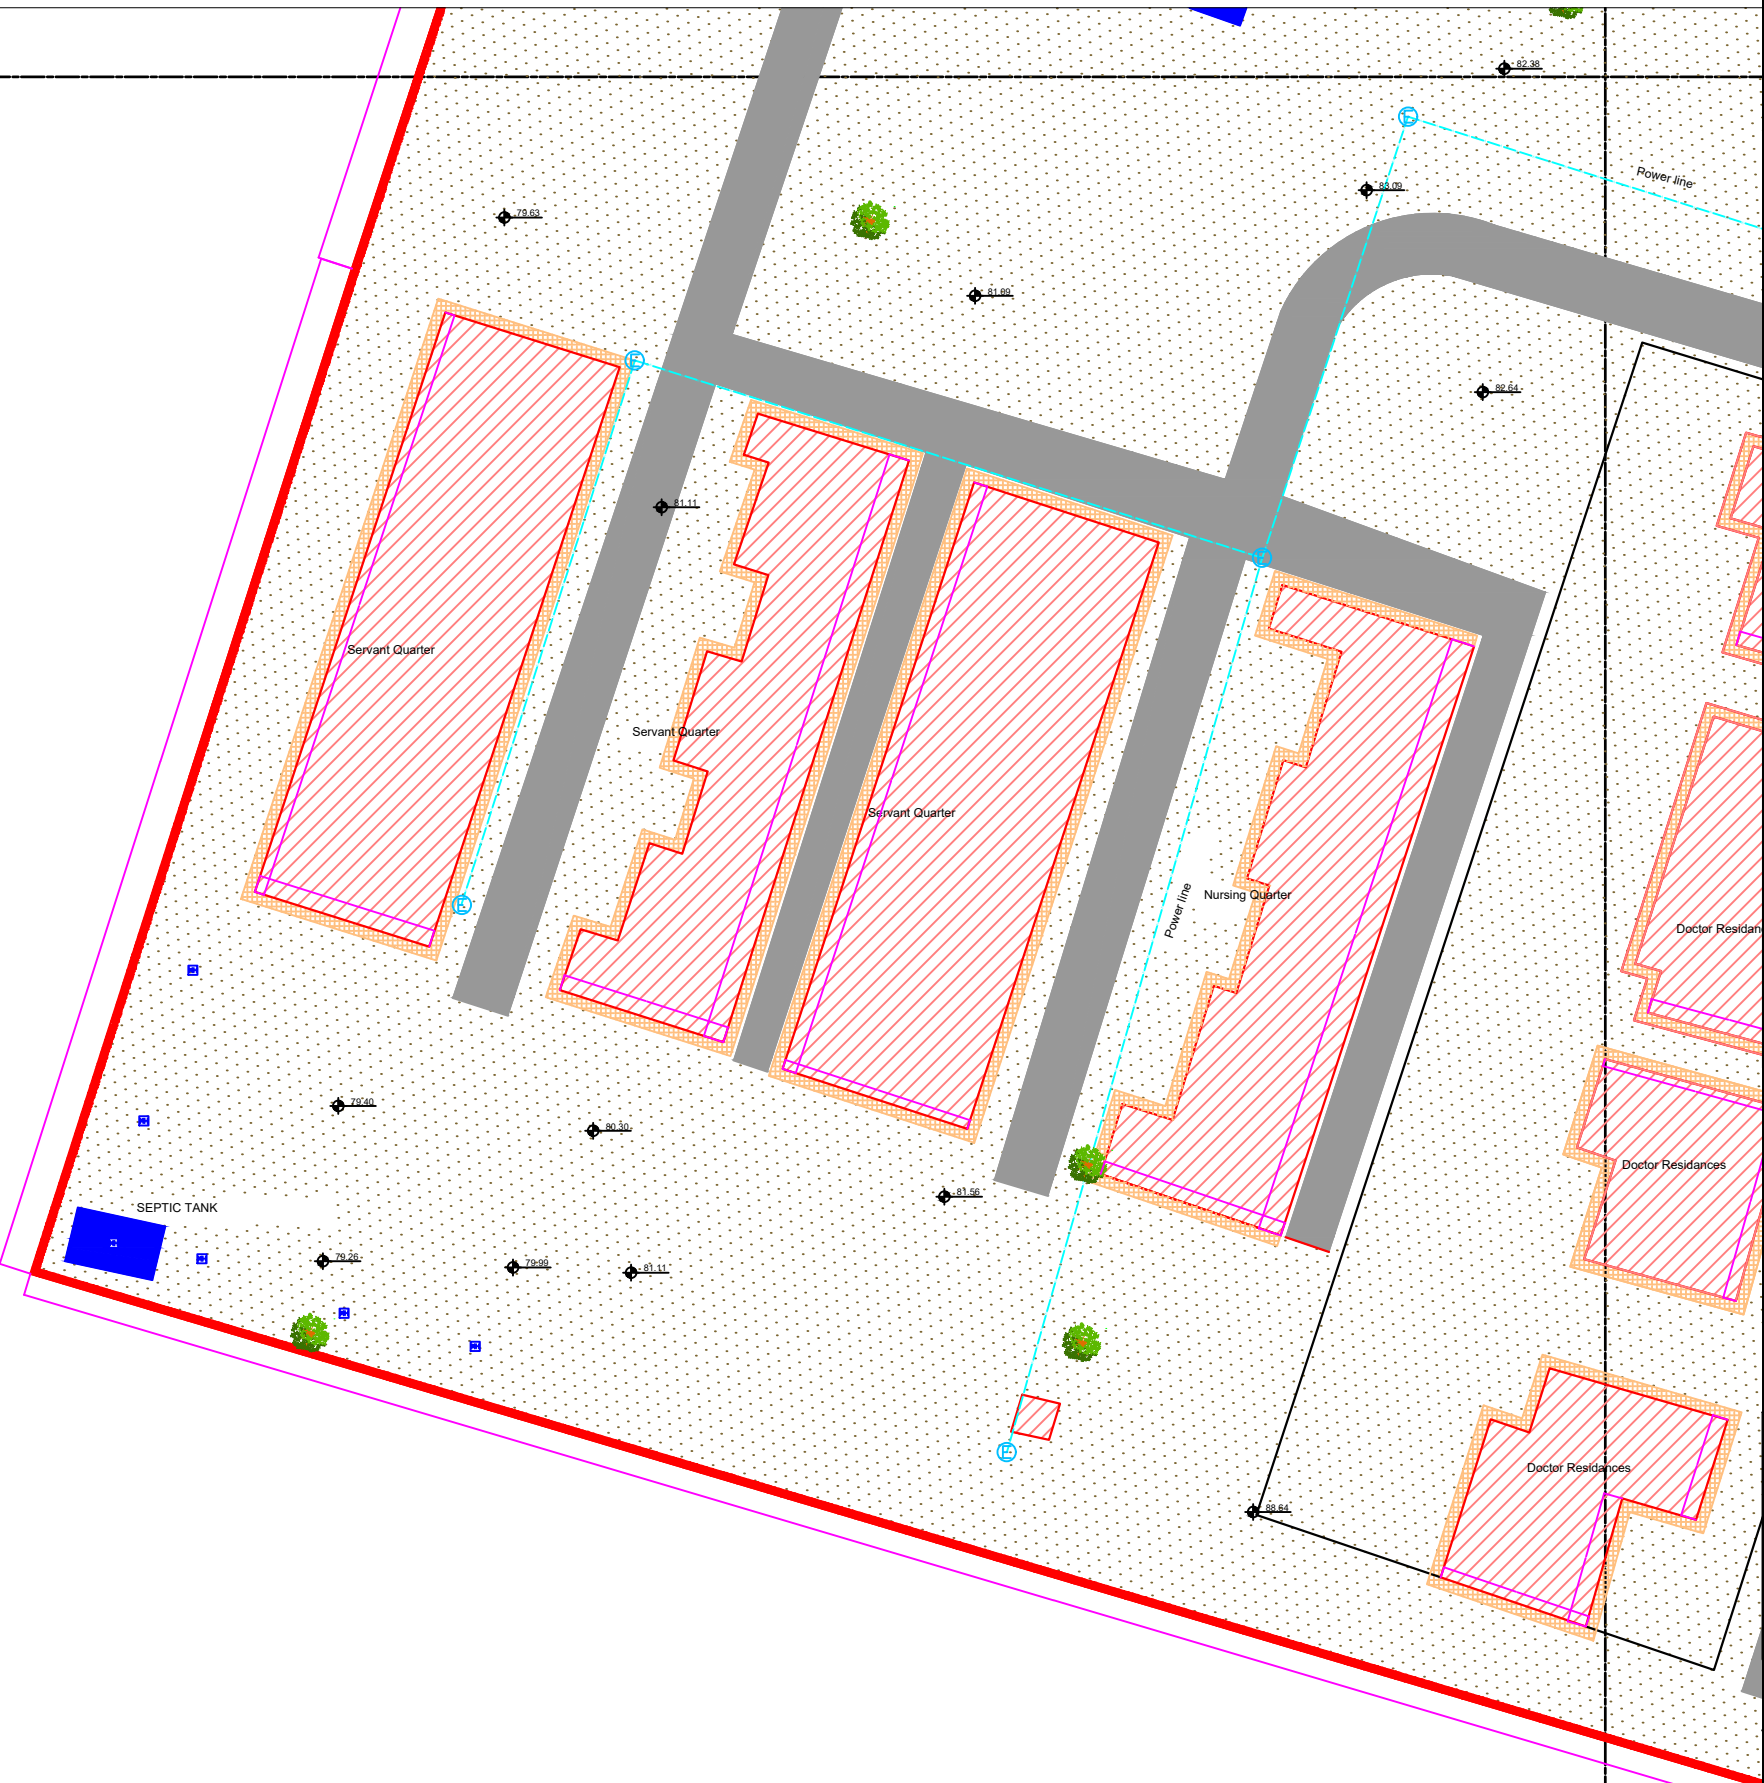

Legends:

Residential Area	
Road	
Wall	
Power Line	
OHT	
Tree	
Man Hole	
Tube Well	
Light Pole	
Lawns	
Earthen Areas	
Asphalts Roads	
Tough Pavers	
P.C.C / Plinth Protection	
Boundary Wall	
Brick Pavers / Soling	
Drain	
Tap	
Hand Pump	
Air Conditioner	
Tube Light	
Fan	
Roof Light	
Bulb	

AREA	
AREA WITHIN BOUNDARY WALL	321750.5 Sft
AREA OF CLINICAL BLOCK	21811.12 Sft
PLINTH AREA OF BLOCK	21811.12 Sft

OPENING SCHEDULE OF DOORS AND WINDOWS					
DOORS	WIDTH	HEIGHT	WINDOWS	WIDTH	HEIGHT
D1	2'-0"	7'-0"	W1	3'-0"	5'-0"
D2	2'-6"	7'-0"	W2	4'-0"	4'-0"
D3	3'-0"	7'-0"	W3	6'-0"	6'-0"
D4	3'-6"	7'-0"	W4	8'-0"	8'-0"
D5	4'-0"	7'-0"	W5	5'-0"	5'-0"
D6	4'-6"	7'-0"	W6		
D7	5'-0"	7'-0"	W7		
D8	6'-0"	7'-0"	V1	2'-0"	2'-0"
D9	7'-0"	7'-0"	V2		

Project:
**CAD MAPPING OF TEHSIL
HEAD QUARTER HOSPITALS,
PUNJAB**



Client: GOVERNMENT OF THE PUNJAB PRIMARY & SECONDARY HEALTHCARE DEPARTMENT	Consultant: SKAFS CONSULTANT (Pvt.) Limited ENGINEERING AND ENVIRONMENT CONSULTANT
---	--

Drawing Title:
**THQ FATEH JANG
HOSPITAL MASTER PLAN PART 3**

Drawing No.
SKAFS/FATEH.J /06

MASTER PLAN OF THQ HOSPITAL FATEH JANG

PART 4

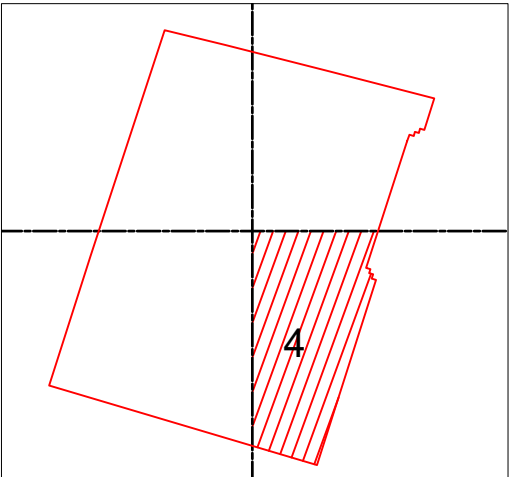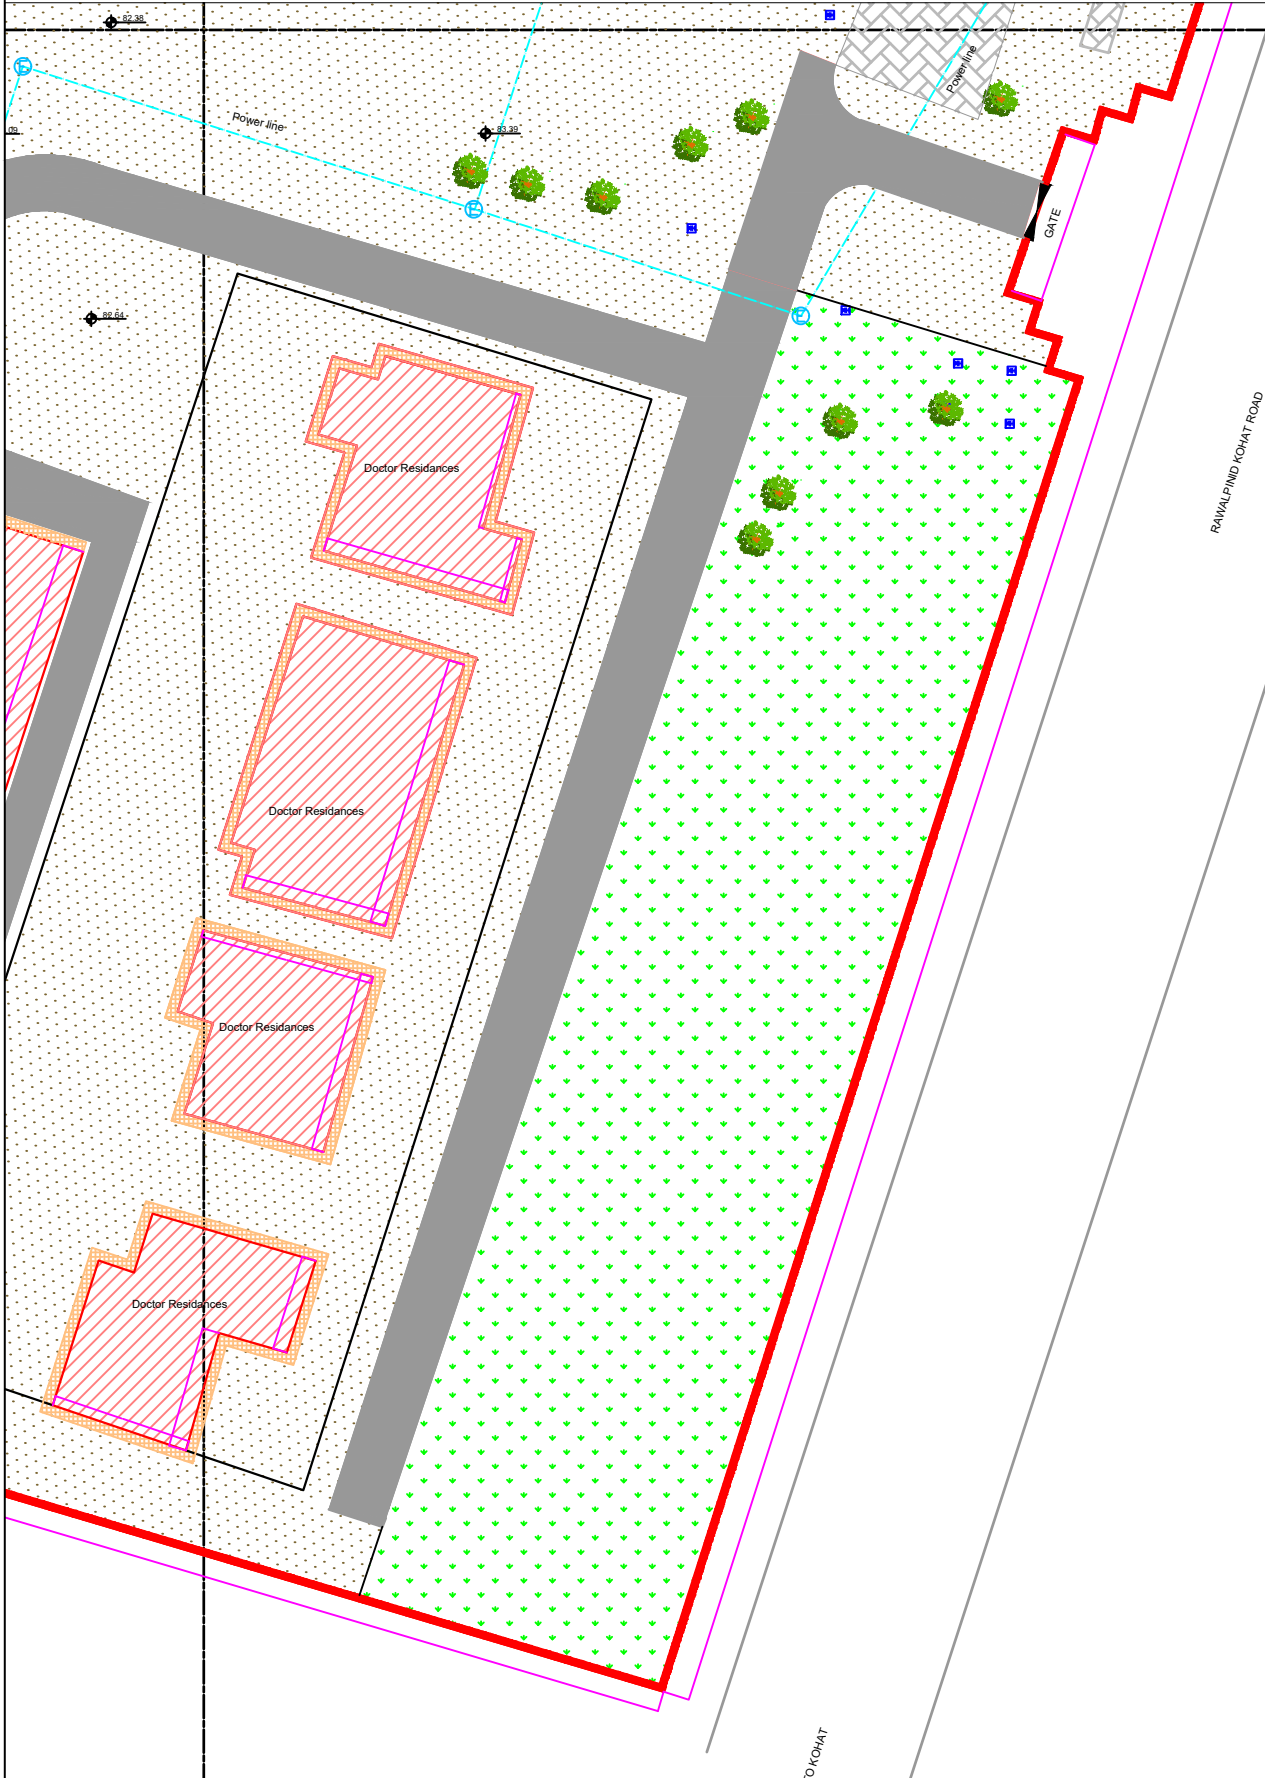

Legends:

Residential Area	
Road	
Wall	
Power Line	
OHT	
Tree	
Man Hole	
Tube Well	
Light Pole	
Lawns	
Earthen Areas	
Asphalts Roads	
Tough Pavers	
P.C.C / Plinth Protection	
Boundary Wall	
Brick Pavers / Soling	
Drain	
Tap	
Hand Pump	
Air Conditioner	
Tube Light	
Fan	
Roof Light	
Bulb	

AREA	
AREA WITHIN BOUNDARY WALL	321750.5 Sft
AREA OF CLINICAL BLOCK	21811.12 Sft
PLINTH AREA OF BLOCK	21811.12 Sft

OPENING SCHEDULE OF DOORS AND WINDOWS					
DOORS	WIDTH	HEIGHT	WINDOWS	WIDTH	HEIGHT
D1	2'-0"	7'-0"	W1	3'-0"	5'-0"
D2	2'-6"	7'-0"	W2	4'-0"	4'-0"
D3	3'-0"	7'-0"	W3	6'-0"	6'-0"
D4	3'-6"	7'-0"	W4	8'-0"	8'-0"
D5	4'-0"	7'-0"	W5	5'-0"	5'-0"
D6	4'-6"	7'-0"	W6		
D7	5'-0"	7'-0"	W7		
D8	6'-0"	7'-0"	V1	2'-0"	2'-0"
D9	7'-0"	7'-0"	V2		

Project:
**CAD MAPPING OF TEHSIL
HEAD QUARTER HOSPITALS,
PUNJAB**

Client: GOVERNMENT OF THE PUNJAB PRIMARY & SECONDARY HEALTHCARE DEPARTMENT	Consultant: SKAFS CONSULTANT (Pvt.) Limited ENGINEERING AND ENVIRONMENT CONSULTANT
---	--

Drawing Title:
**THQ FATEH JANG
HOSPITAL MASTER PLAN PART 4**

Drawing No.
SKAFS/FATEH.J /07

CLINICAL BLOCK OF THQ HOSPITAL FATEH JANG

GROUND FLOOR

PART 1

PART 2

PART 3

PART 4

Legends:

Residential Area	
Road	
Wall	
Power Line	
OHT	
Tree	
Man Hole	
Tube Well	
Light Pole	
Lawns	
Earthen Areas	
Asphalts Roads	
Tough Pavers	
P.C.C / Plinth Protection	
Boundary Wall	
Brick Pavers / Soling	
Drain	
Tap	
Hand Pump	
Air Conditioner	
Tube Light	
Fan	
Roof Light	
Bulb	

AREA

AREA WITHIN BOUNDARY WALL	321750.5 Sft
AREA OF CLINICAL BLOCK	21811.12 Sft
PLINTH AREA OF BLOCK	21811.12 Sft

OPENING SCHEDULE OF DOORS AND WINDOWS

DOORS	WIDTH	HEIGHT	WINDOWS	WIDTH	HEIGHT
D1	2'-0"	7'-0"	W1	3'-0"	5'-0"
D2	2'-6"	7'-0"	W2	4'-0"	4'-0"
D3	3'-0"	7'-0"	W3	6'-0"	6'-0"
D4	3'-6"	7'-0"	W4	8'-0"	8'-0"
D5	4'-0"	7'-0"	W5	5'-0"	5'-0"
D6	4'-6"	7'-0"	W6		
D7	5'-0"	7'-0"	W7		
D8	6'-0"	7'-0"	V1	2'-0"	2'-0"
D9	7'-0"	7'-0"	V2		

Project:
**CAD MAPPING OF TEHSIL
HEAD QUARTER HOSPITALS,
PUNJAB**


Client: GOVERNMENT OF THE PUNJAB PRIMARY & SECONDARY HEALTHCARE DEPARTMENT	Consultant: SKAFS CONSULTANT (Pvt.) Limited ENGINEERING AND ENVIRONMENT CONSULTANT
---	--

Drawing Title:
**THQ FATEH JANG
HOSPITAL CLINICAL BLOCK PLAN**

Drawing No.
SKAFS/FATEH.J /08

CLINICAL BLOCK OF THQ HOSPITAL FATEH JANG

GROUND FLOOR PART 1

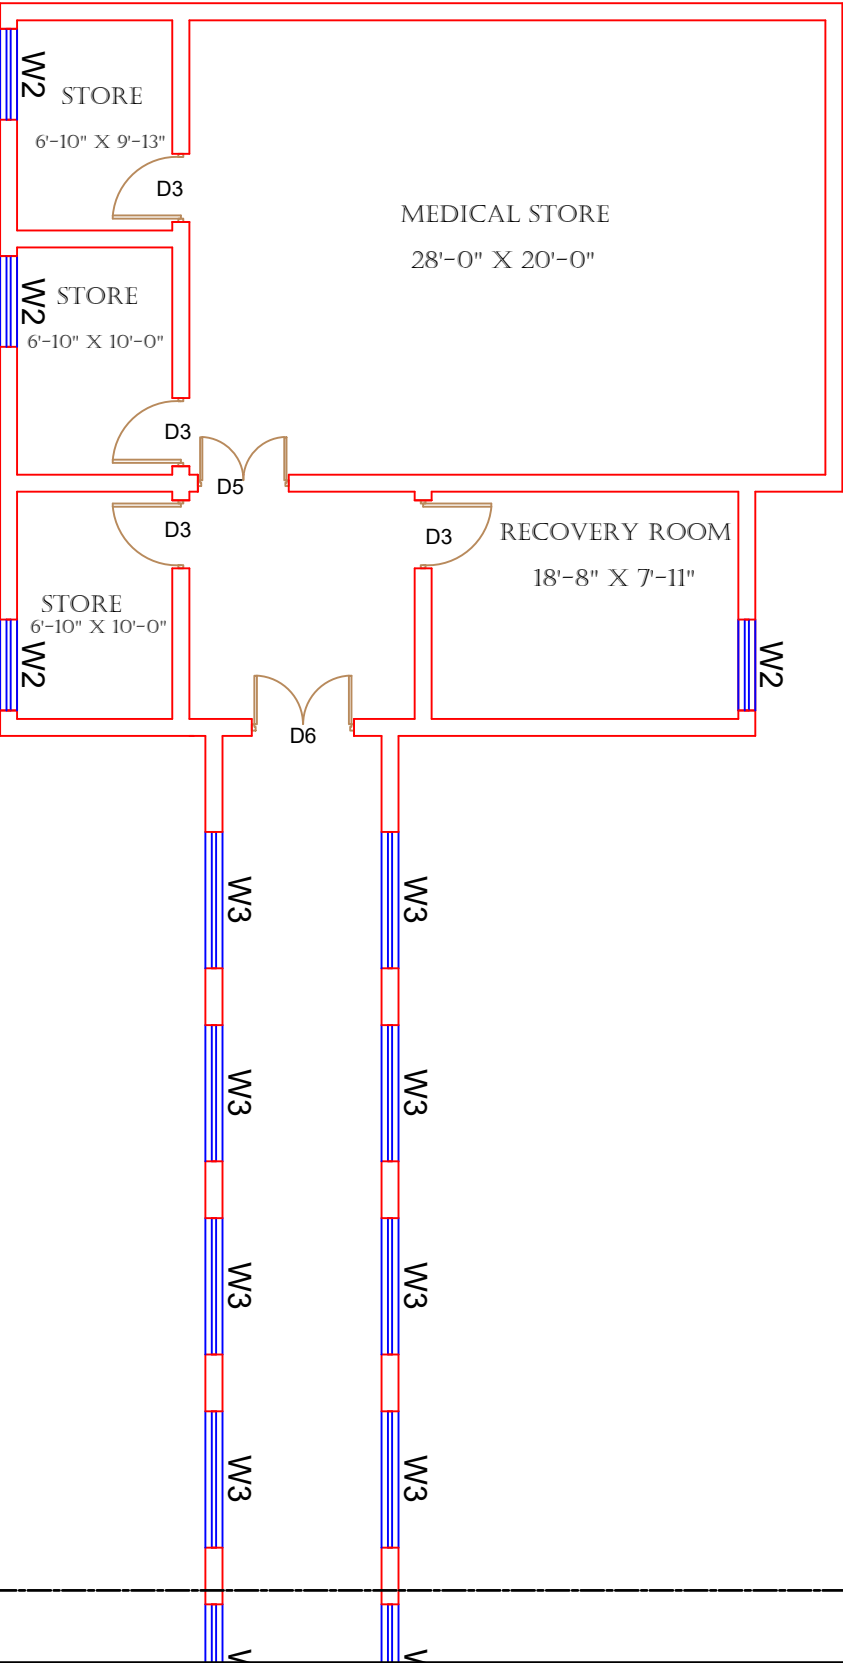

Legends:

Residential Area	
Road	
Wall	
Power Line	
OHT	
Tree	
Man Hole	
Tube Well	
Light Pole	
Lawns	
Earthen Areas	
Asphalts Roads	
Tough Pavers	
P.C.C / Plinth Protection	
Boundary Wall	
Brick Pavers / Soling	
Drain	
Tap	
Hand Pump	
Air Conditioner	
Tube Light	
Fan	
Roof Light	
Bulb	

AREA	
AREA WITHIN BOUNDARY WALL	321750.5 Sft
AREA OF CLINICAL BLOCK	21811.12 Sft
PLINTH AREA OF BLOCK	21811.12 Sft

OPENING SCHEDULE OF DOORS AND WINDOWS					
DOORS	WIDTH	HEIGHT	WINDOWS	WIDTH	HEIGHT
D1	2'-0"	7'-0"	W1	3'-0"	5'-0"
D2	2'-6"	7'-0"	W2	4'-0"	4'-0"
D3	3'-0"	7'-0"	W3	6'-0"	6'-0"
D4	3'-6"	7'-0"	W4	8'-0"	8'-0"
D5	4'-0"	7'-0"	W5	5'-0"	5'-0"
D6	4'-6"	7'-0"	W6		
D7	5'-0"	7'-0"	W7		
D8	6'-0"	7'-0"	V1	2'-0"	2'-0"
D9	7'-0"	7'-0"	V2		

Project:

**CAD MAPPING OF TEHSIL
HEAD QUARTER HOSPITALS,
PUNJAB**

Client:	Consultant:
 GOVERNMENT OF THE PUNJAB PRIMARY & SECONDARY HEALTHCARE DEPARTMENT	 SKAFS CONSULTANT (Pvt.) Limited ENGINEERING AND ENVIRONMENT CONSULTANT

Drawing Title:


**THQ FATEH JANG
CLINICAL BLOCK PLAN (PART 1)**

Drawing No.

SKAFS/FATEH.J /09

CLINICAL BLOCK OF THQ HOSPITAL FATEH JANG

GROUND FLOOR PART 2

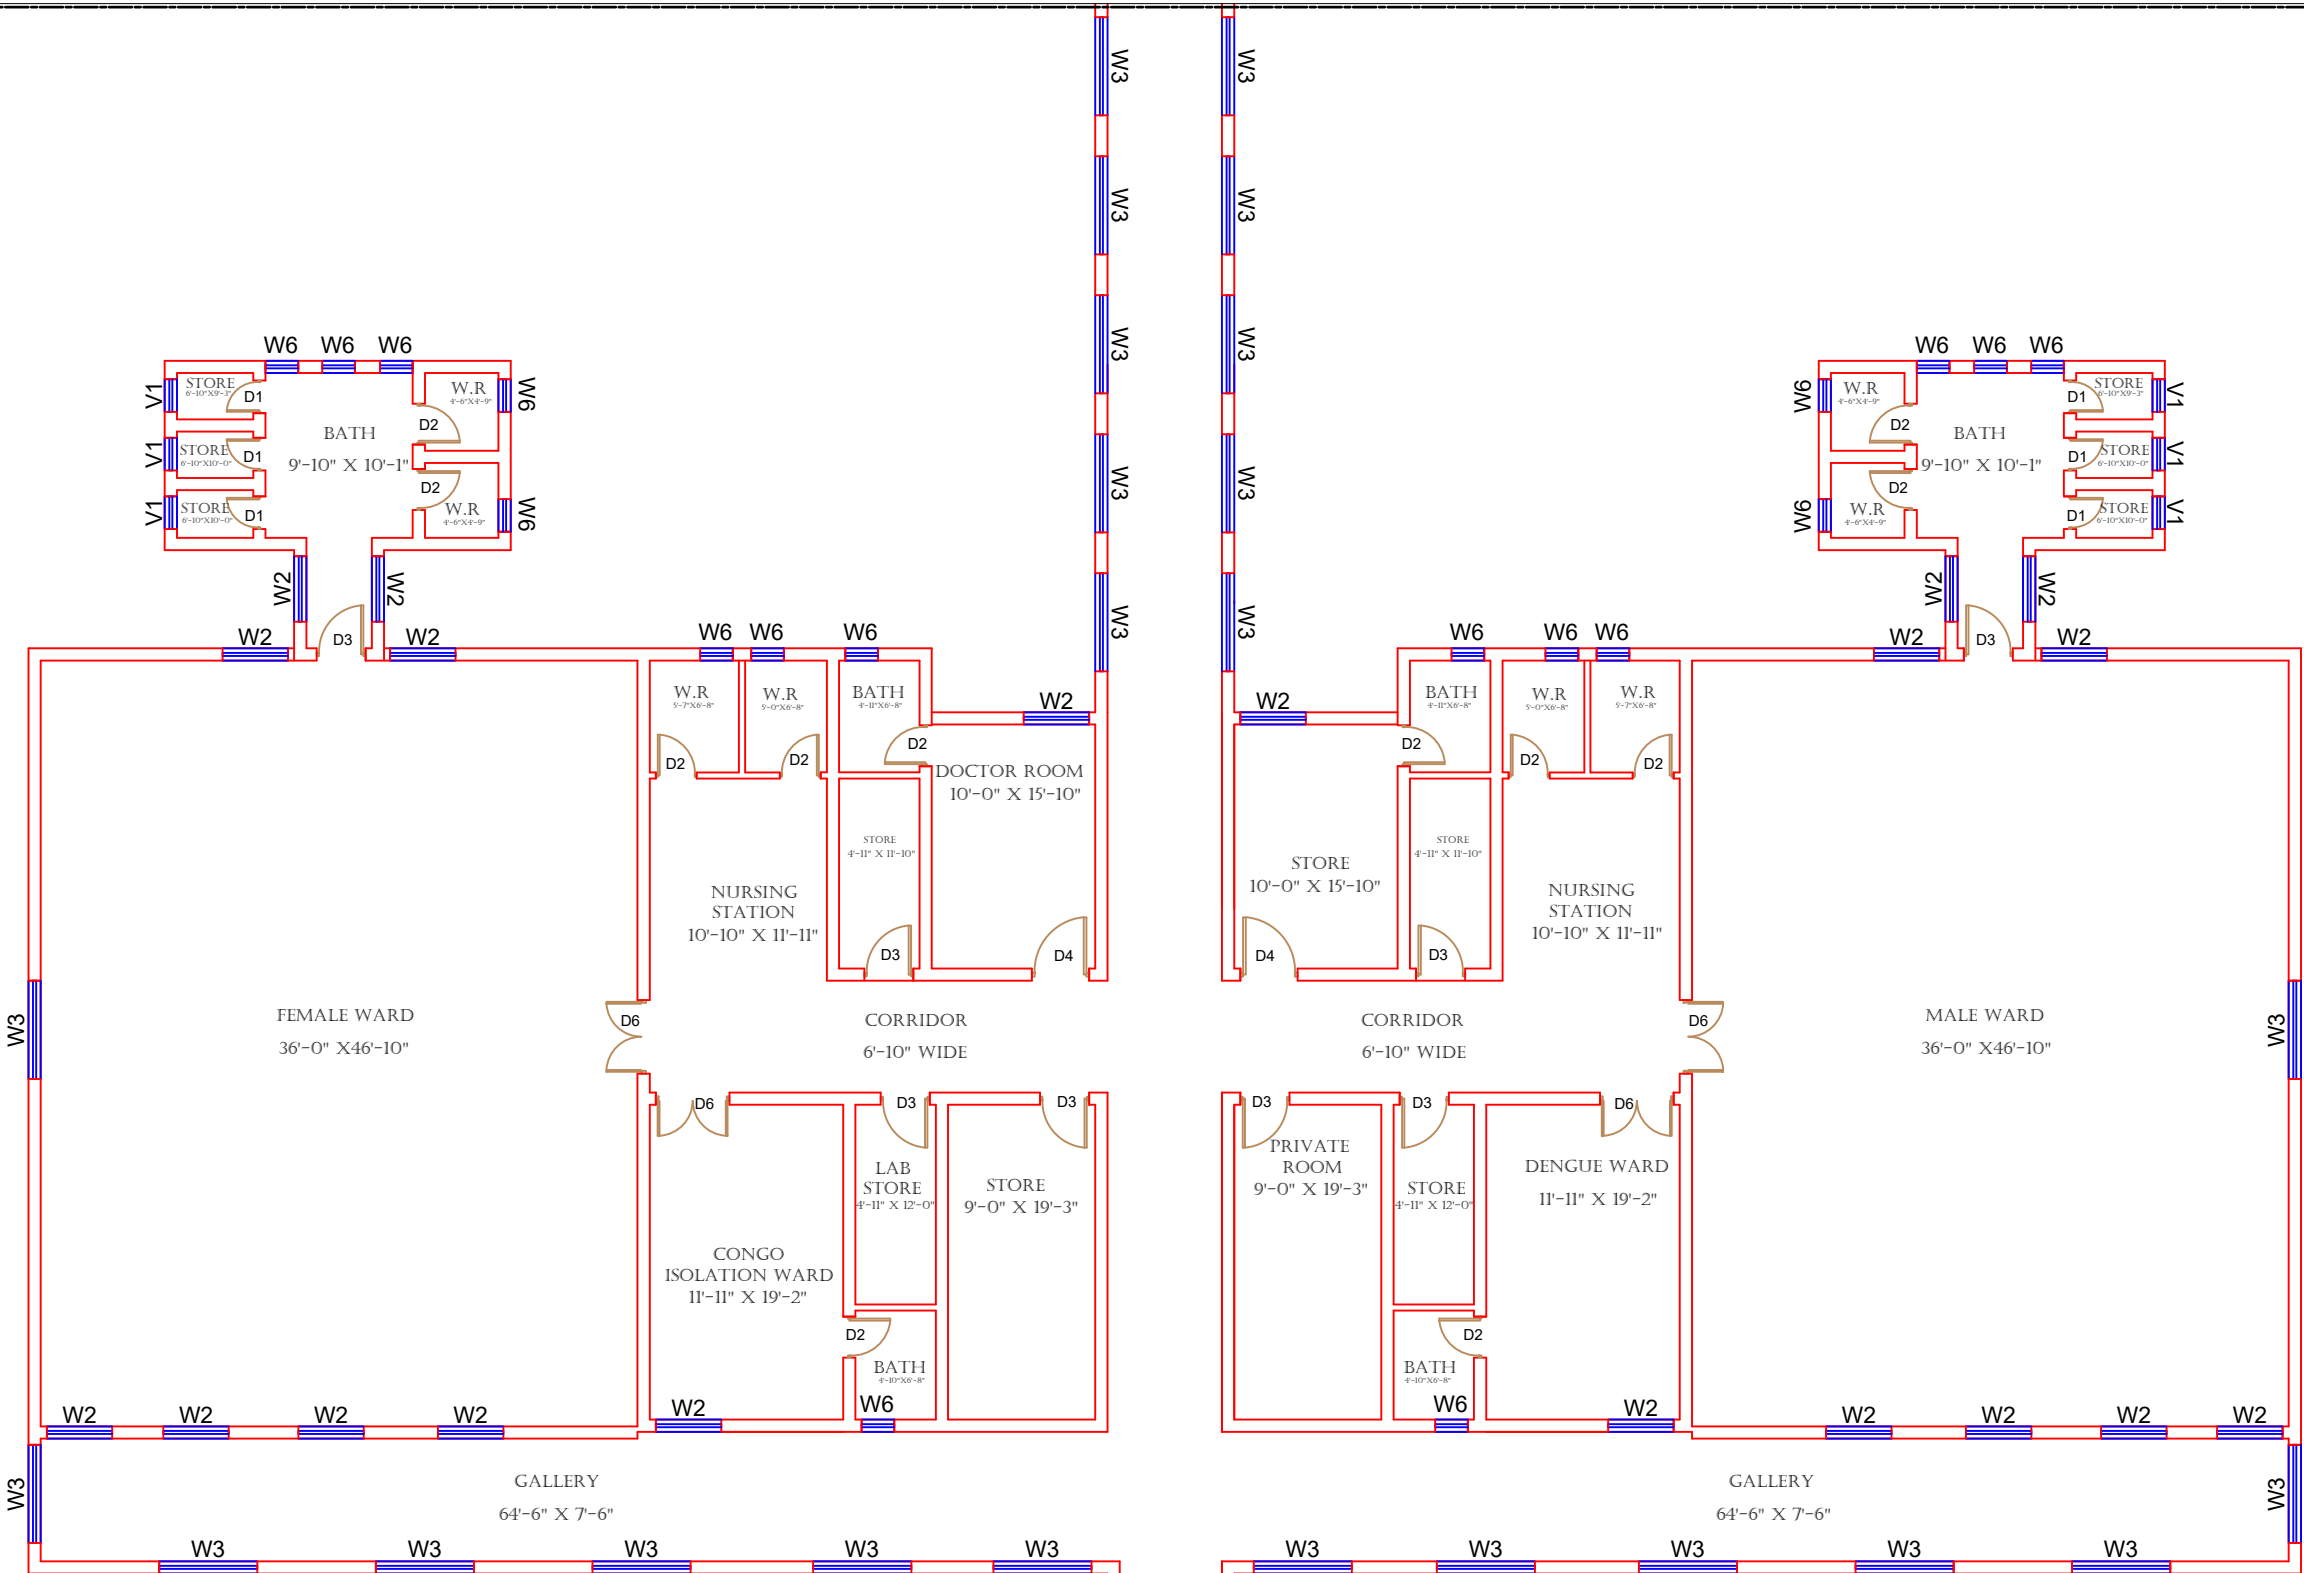

Legends:

Residential Area	
Road	
Wall	
Power Line	
OHT	
Tree	
Man Hole	
Tube Well	
Light Pole	
Lawns	
Earthen Areas	
Asphalts Roads	
Tough Pavers	
P.C.C / Plinth Protection	
Boundary Wall	
Brick Pavers / Soling	
Drain	
Tap	
Hand Pump	
Air Conditioner	
Tube Light	
Fan	
Roof Light	
Bulb	

AREA	
AREA WITHIN BOUNDARY WALL	321750.5 Sft
AREA OF CLINICAL BLOCK	21811.12 Sft
PLINTH AREA OF BLOCK	21811.12 Sft

OPENING SCHEDULE OF DOORS AND WINDOWS					
DOORS	WIDTH	HEIGHT	WINDOWS	WIDTH	HEIGHT
D1	2'-0"	7'-0"	W1	3'-0"	5'-0"
D2	2'-6"	7'-0"	W2	4'-0"	4'-0"
D3	3'-0"	7'-0"	W3	6'-0"	6'-0"
D4	3'-6"	7'-0"	W4	8'-0"	8'-0"
D5	4'-0"	7'-0"	W5	5'-0"	5'-0"
D6	4'-6"	7'-0"	W6		
D7	5'-0"	7'-0"	W7		
D8	6'-0"	7'-0"	V1	2'-0"	2'-0"
D9	7'-0"	7'-0"	V2		

Project:
CAD MAPPING OF TEHSIL HEAD QUARTER HOSPITALS, PUNJAB


Client: GOVERNMENT OF THE PUNJAB PRIMARY & SECONDARY HEALTHCARE DEPARTMENT	Consultant: SKAFS CONSULTANT (Pvt.) Limited ENGINEERING AND ENVIRONMENT CONSULTANT
---	--

Drawing Title:
**THQ FATEH JANG
CLINICAL BLOCK PLAN (PART 2)**

Drawing No.
SKAFS/FATEH.J /10

CLINICAL BLOCK OF THQ HOSPITAL FATEH JANG

GROUND FLOOR PART 3

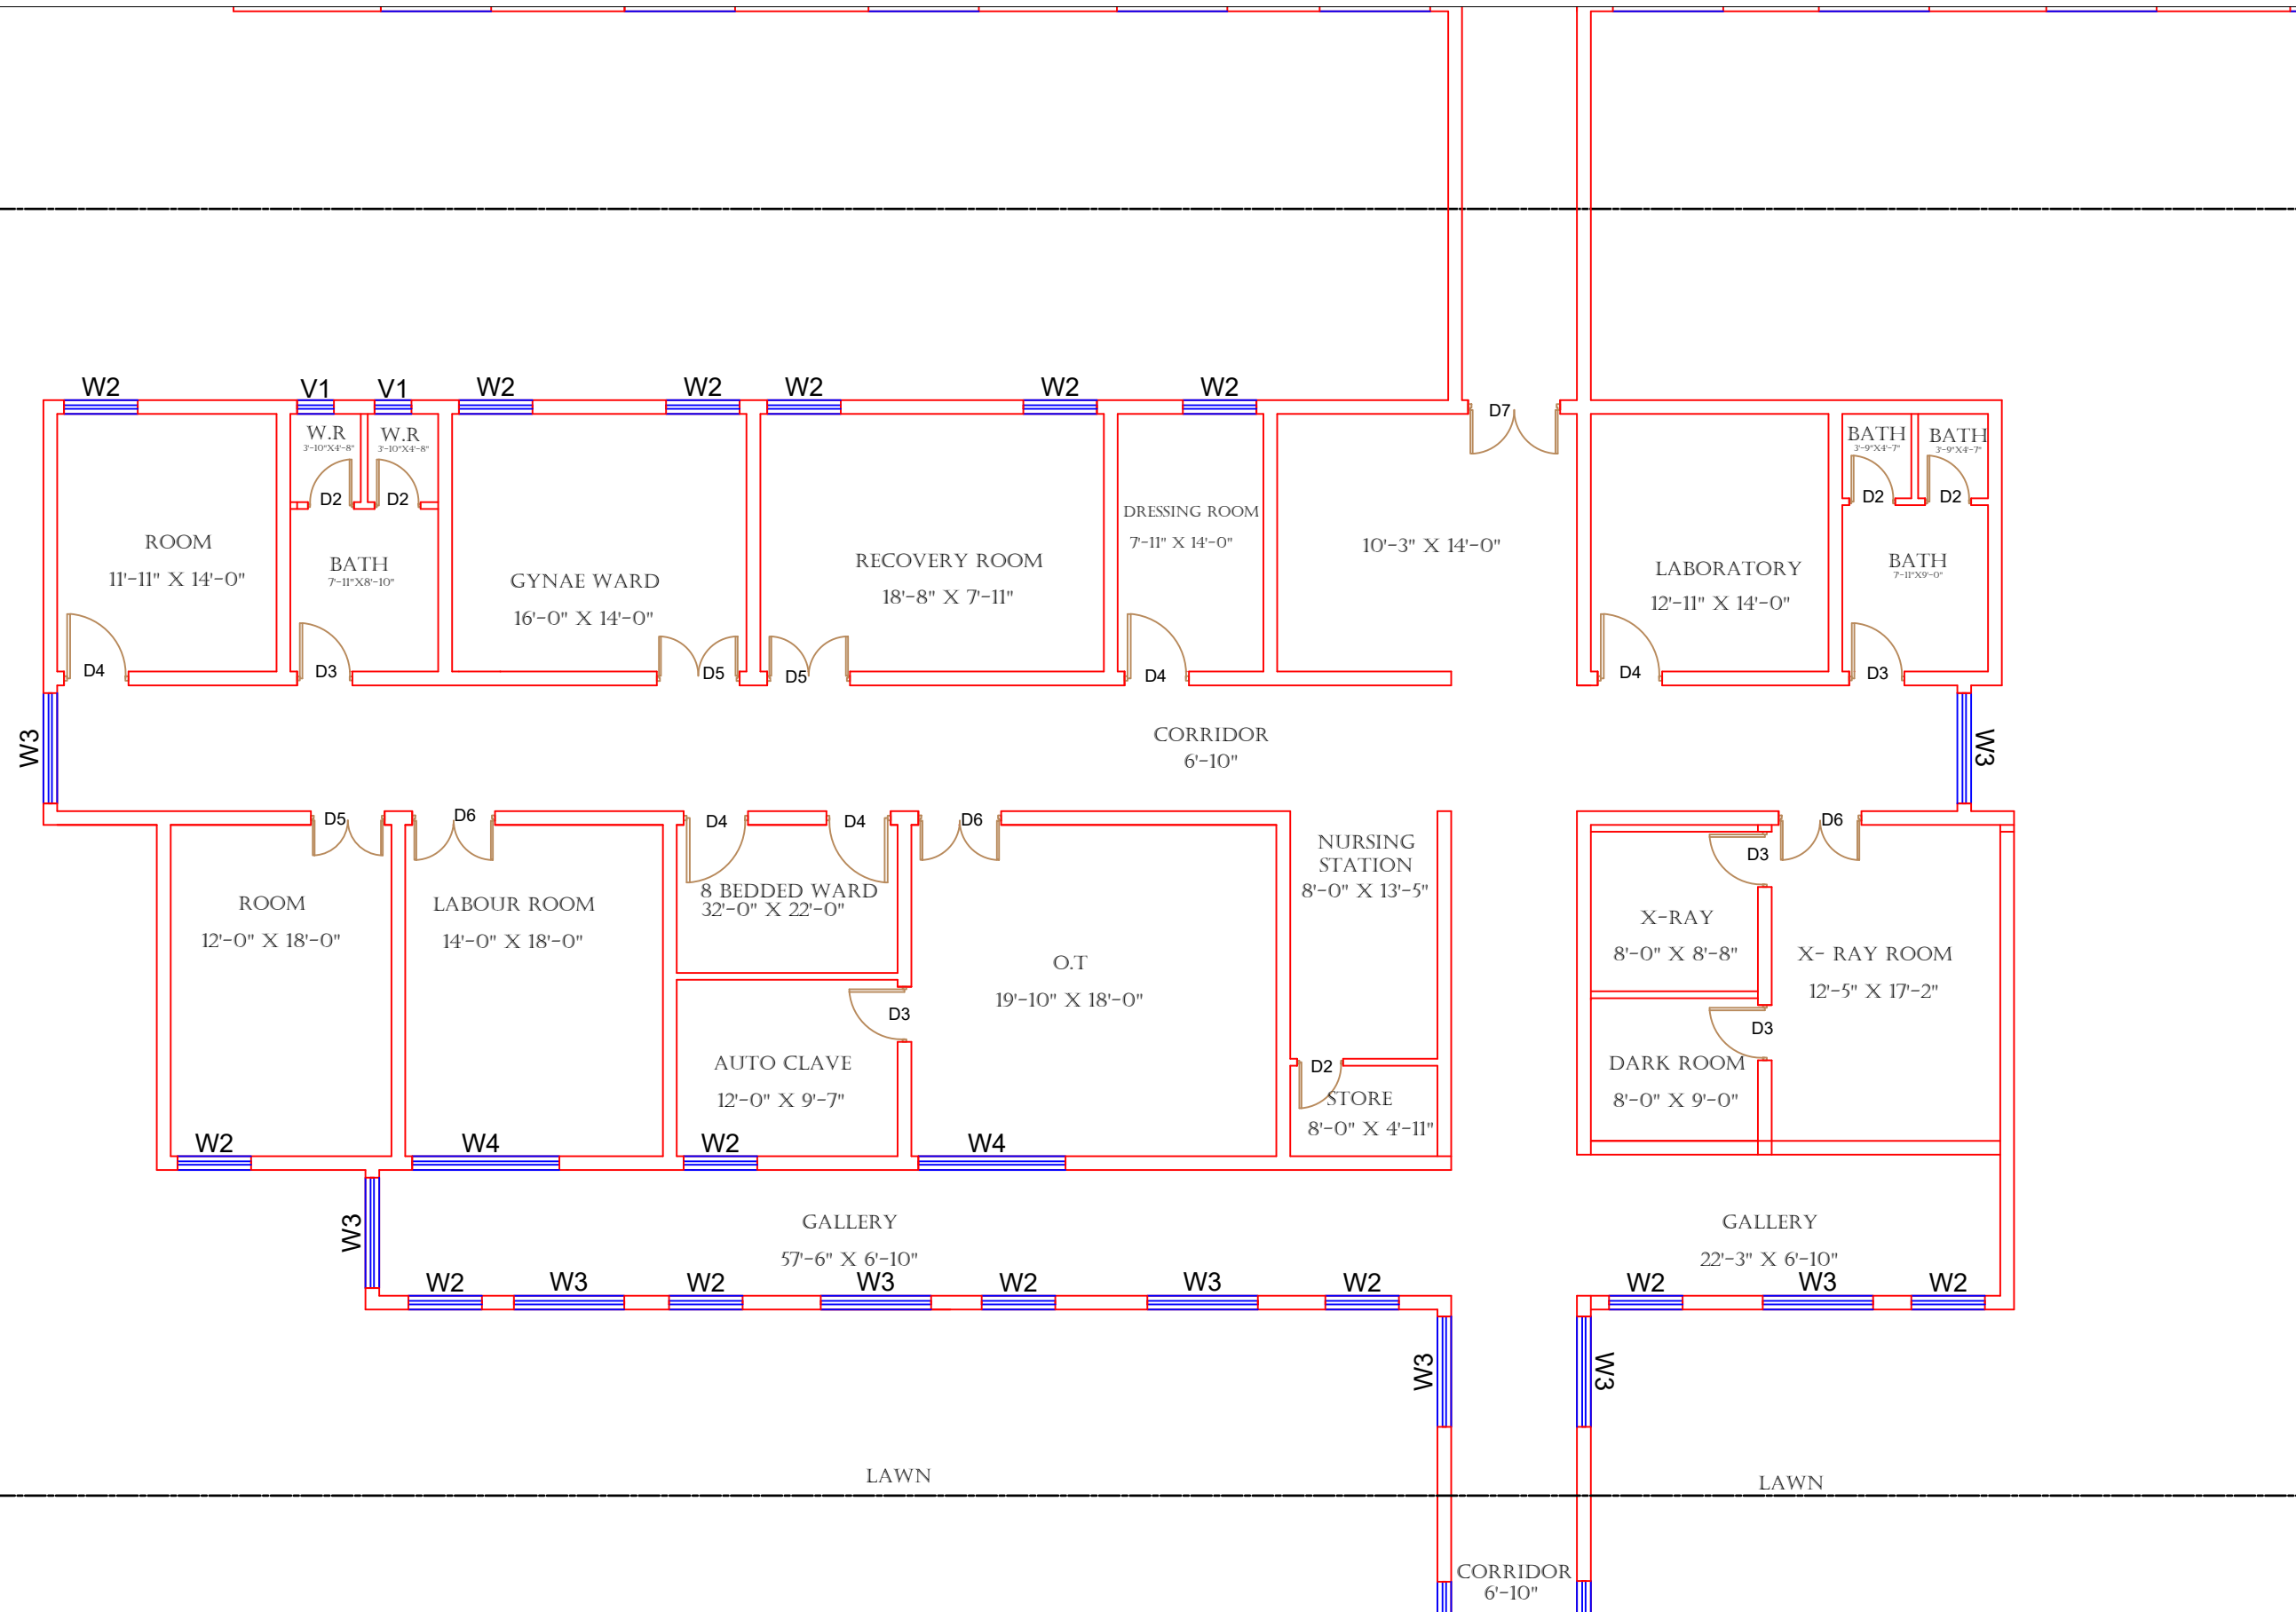

Legends:

Residential Area	
Road	
Wall	
Power Line	
OHT	
Tree	
Man Hole	
Tube Well	
Light Pole	
Lawns	
Earthen Areas	
Asphalts Roads	
Tough Pavers	
P.C.C / Plinth Protection	
Boundary Wall	
Brick Pavers / Soling	
Drain	
Tap	
Hand Pump	
Air Conditioner	
Tube Light	
Fan	
Roof Light	
Bulb	

AREA	
AREA WITHIN BOUNDARY WALL	321750.5 Sft
AREA OF CLINICAL BLOCK	21811.12 Sft
PLINTH AREA OF BLOCK	21811.12 Sft

OPENING SCHEDULE OF DOORS AND WINDOWS					
DOORS	WIDTH	HEIGHT	WINDOWS	WIDTH	HEIGHT
D1	2'-0"	7'-0"	W1	3'-0"	5'-0"
D2	2'-6"	7'-0"	W2	4'-0"	4'-0"
D3	3'-0"	7'-0"	W3	6'-0"	6'-0"
D4	3'-6"	7'-0"	W4	8'-0"	8'-0"
D5	4'-0"	7'-0"	W5	5'-0"	5'-0"
D6	4'-6"	7'-0"	W6		
D7	5'-0"	7'-0"	W7		
D8	6'-0"	7'-0"	V1	2'-0"	2'-0"
D9	7'-0"	7'-0"	V2		

Project: **CAD MAPPING OF TEHSIL HEAD QUARTER HOSPITALS, PUNJAB**


Client:	Consultant:
GOVERNMENT OF THE PUNJAB PRIMARY & SECONDARY HEALTHCARE DEPARTMENT	SKAFS CONSULTANT (Pvt.) Limited ENGINEERING AND ENVIRONMENT CONSULTANT

Drawing Title: **THQ FATEH JANG CLINICAL BLOCK PLAN (PART 3)**

Drawing No. **SKAFS/FATEH.J /11**

CLINICAL BLOCK OF THQ HOSPITAL FATEH JANG

GROUND FLOOR PART 4

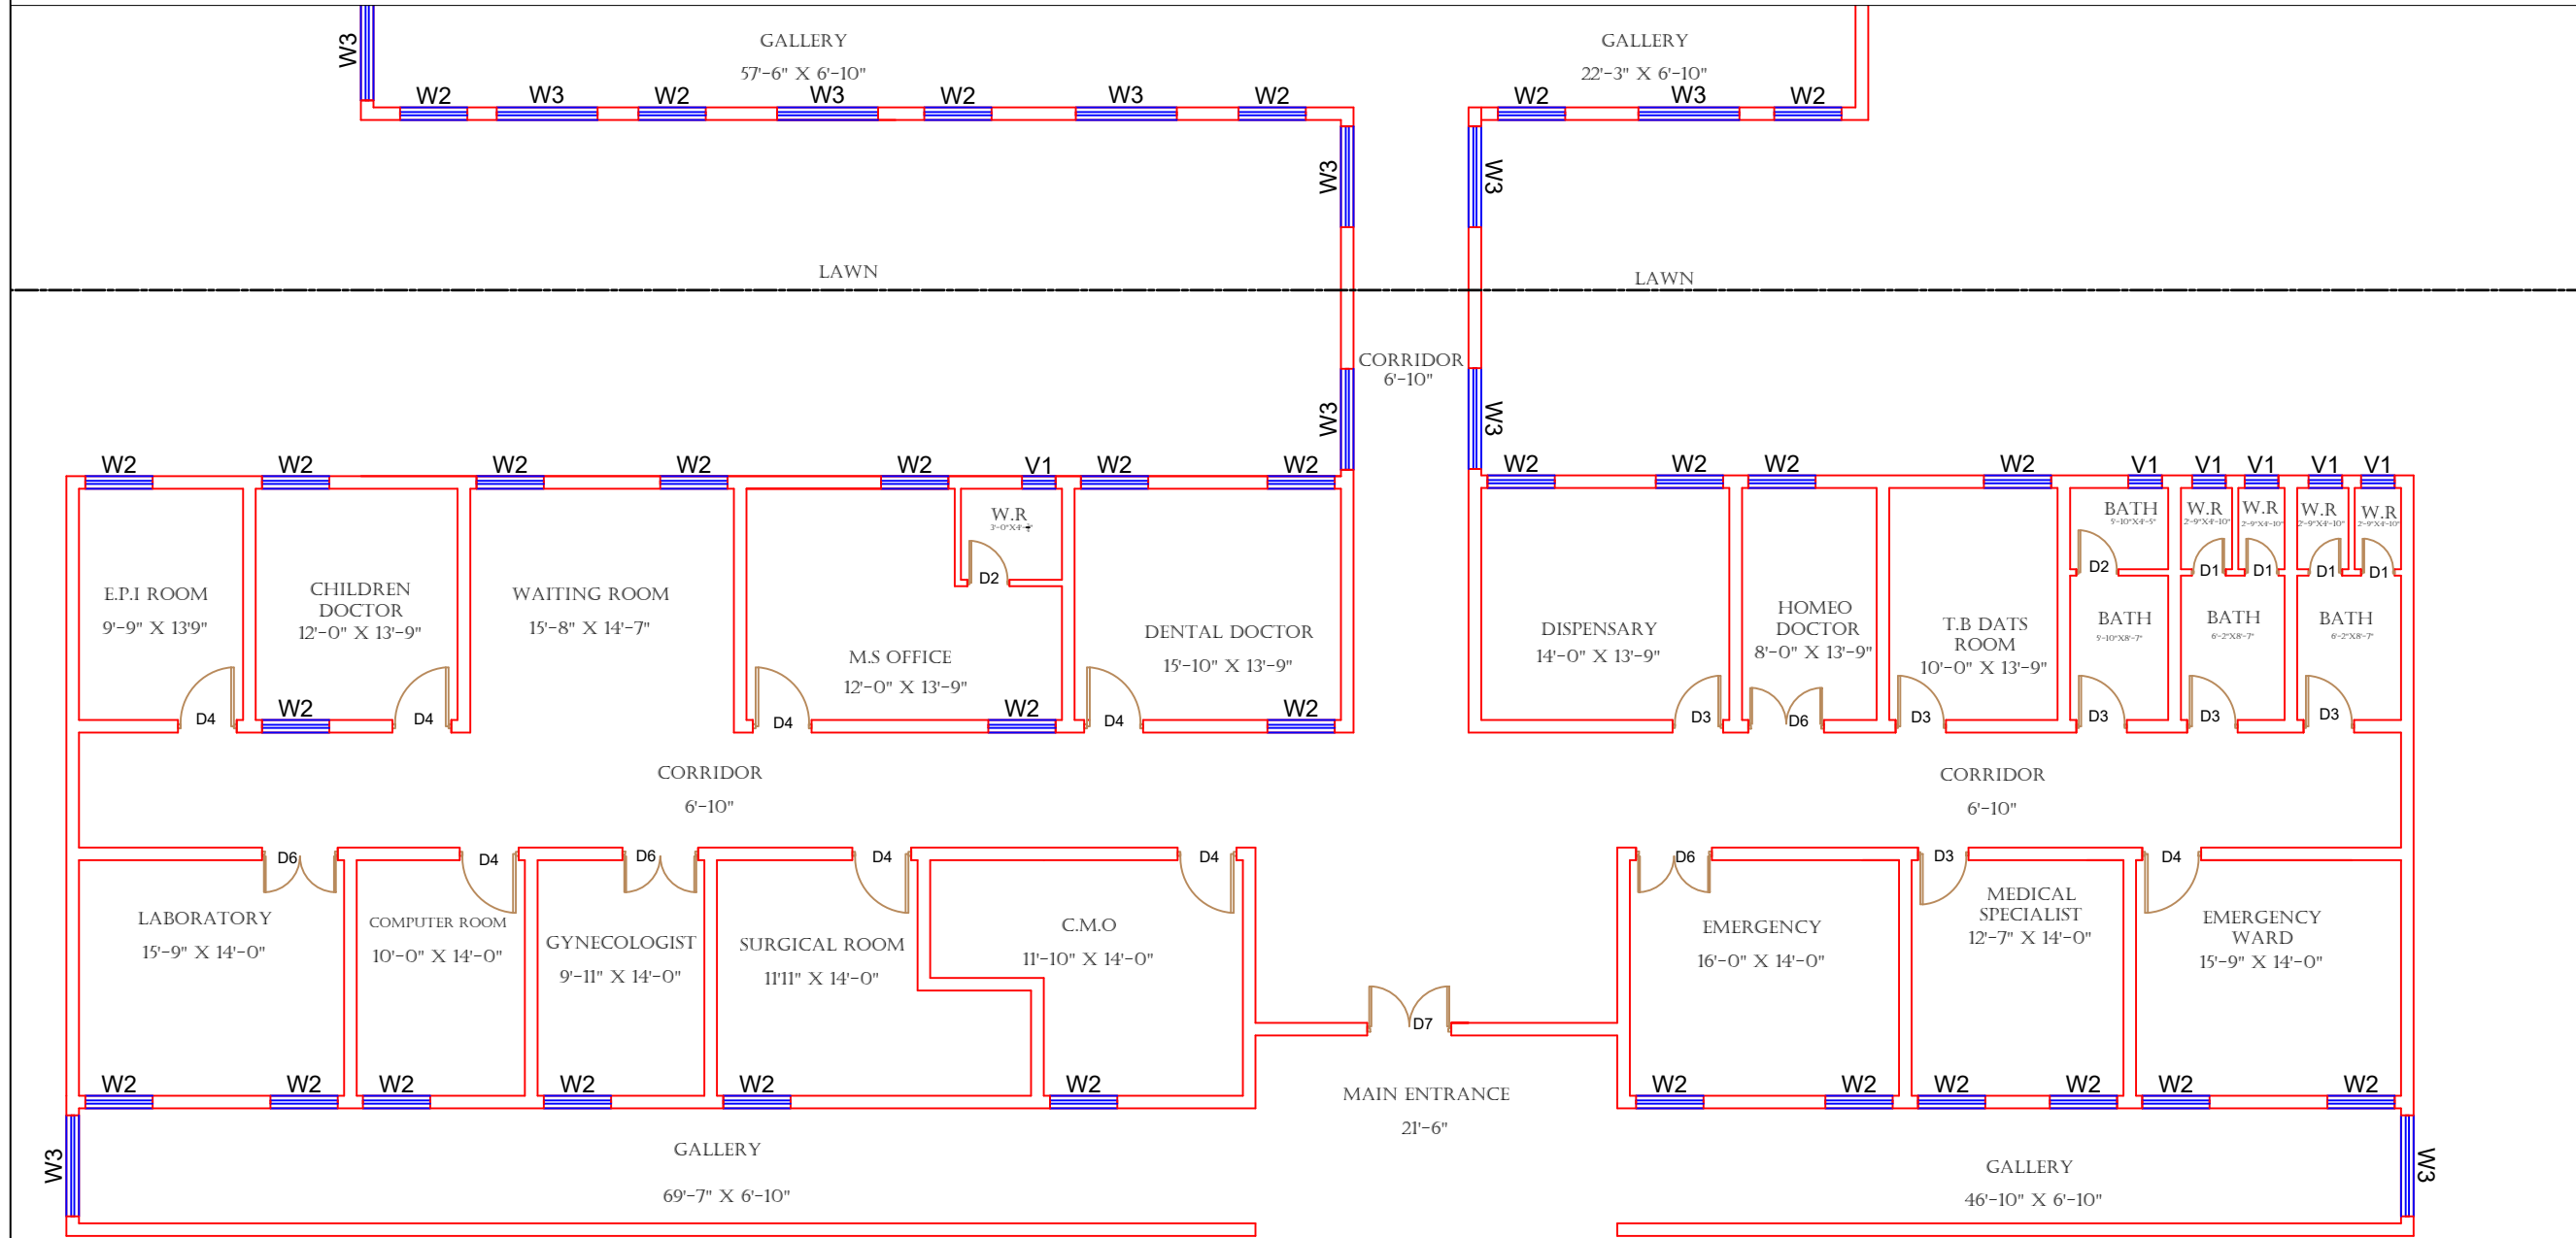

Legends:

Residential Area	
Road	
Wall	
Power Line	
OHT	
Tree	
Man Hole	
Tube Well	
Light Pole	
Lawns	
Earthen Areas	
Asphalts Roads	
Tough Pavers	
P.C.C / Plinth Protection	
Boundary Wall	
Brick Pavers / Soling	
Drain	
Tap	
Hand Pump	
Air Conditioner	
Tube Light	
Fan	
Roof Light	
Bulb	

AREA	
AREA WITHIN BOUNDARY WALL	321750.5 Sft
AREA OF CLINICAL BLOCK	21811.12 Sft
PLINTH AREA OF BLOCK	21811.12 Sft

OPENING SCHEDULE OF DOORS AND WINDOWS					
DOORS	WIDTH	HEIGHT	WINDOWS	WIDTH	HEIGHT
D1	2'-0"	7'-0"	W1	3'-0"	5'-0"
D2	2'-6"	7'-0"	W2	4'-0"	4'-0"
D3	3'-0"	7'-0"	W3	6'-0"	6'-0"
D4	3'-6"	7'-0"	W4	8'-0"	8'-0"
D5	4'-0"	7'-0"	W5	5'-0"	5'-0"
D6	4'-6"	7'-0"	W6		
D7	5'-0"	7'-0"	W7		
D8	6'-0"	7'-0"	V1	2'-0"	2'-0"
D9	7'-0"	7'-0"	V2		

Project:
**CAD MAPPING OF TEHSIL
HEAD QUARTER HOSPITALS,
PUNJAB**

Client:

GOVERNMENT OF THE PUNJAB
PRIMARY & SECONDARY
HEALTHCARE DEPARTMENT

Consultant:


SKAFS CONSULTANT (Pvt.)
Limited
ENGINEERING AND ENVIRONMENT
CONSULTANT

Drawing Title:
**THQ FATEH JANG
CLINICAL BLOCK PLAN (PART 4)**

Drawing No.
SKAFS/FATEH.J /12

ELECTRICAL LAYOUT PLAN OF THQ HOSPITAL FATEH JANG

GROUND FLOOR

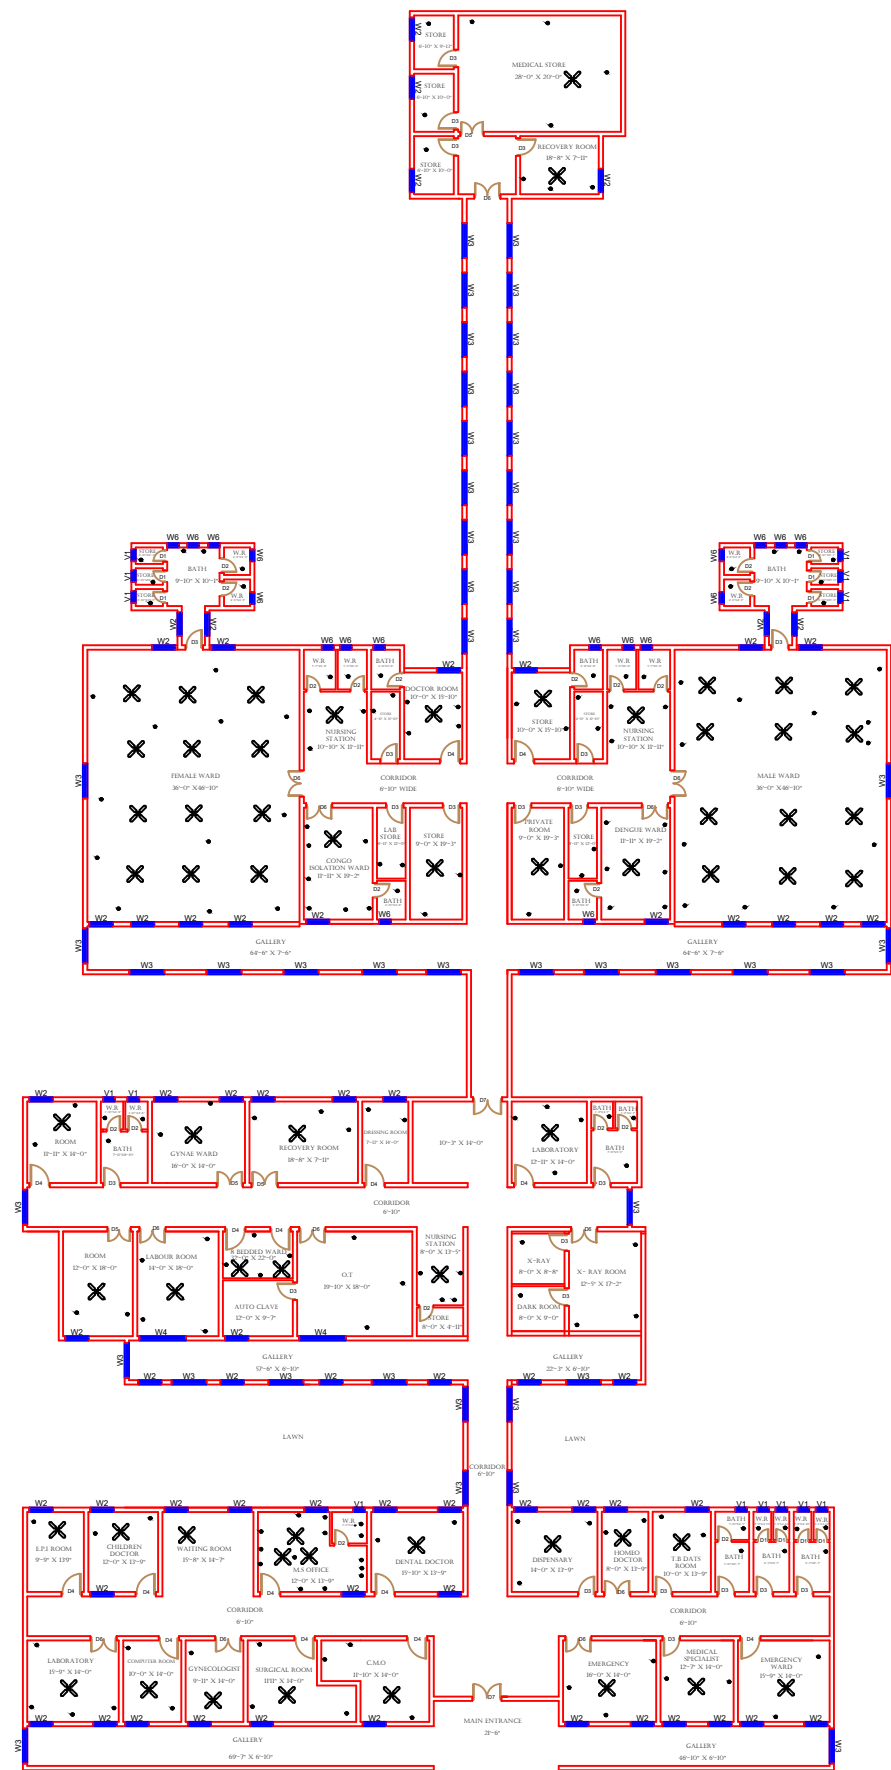

Legends:

Residential Area	
Road	
Wall	
Power Line	
OHT	
Tree	
Man Hole	
Tube Well	
Light Pole	
Lawns	
Earthen Areas	
Asphalts Roads	
Tough Pavers	
P.C.C / Plinth Protection	
Boundary Wall	
Brick Pavers / Soling	
Drain	
Tap	
Hand Pump	
Air Conditioner	
Tube Light	
Fan	
Roof Light	
Bulb	

AREA

AREA WITHIN BOUNDARY WALL	321750.5 Sft
AREA OF CLINICAL BLOCK	21811.12 Sft
PLINTH AREA OF BLOCK	21811.12 Sft

OPENING SCHEDULE OF DOORS AND WINDOWS

DOORS	WIDTH	HEIGHT	WINDOWS	WIDTH	HEIGHT
D1	2'-0"	7'-0"	W1	3'-0"	5'-0"
D2	2'-6"	7'-0"	W2	4'-0"	4'-0"
D3	3'-0"	7'-0"	W3	6'-0"	6'-0"
D4	3'-6"	7'-0"	W4	8'-0"	8'-0"
D5	4'-0"	7'-0"	W5	5'-0"	5'-0"
D6	4'-6"	7'-0"	W6		
D7	5'-0"	7'-0"	W7		
D8	6'-0"	7'-0"	V1	2'-0"	2'-0"
D9	7'-0"	7'-0"	V2		

Project:
**CAD MAPPING OF TEHSIL
HEAD QUARTER HOSPITALS,
PUNJAB**

Client: GOVERNMENT OF THE PUNJAB PRIMARY & SECONDARY HEALTHCARE DEPARTMENT	Consultant: SKAFS CONSULTANT (Pvt.) Limited ENGINEERING AND ENVIRONMENT CONSULTANT
---	--

Drawing Title:
**THQ FATEH JANG
ELECTRICAL PLAN (GROUND FLOOR)**

Drawing No.
SKAFS/FATEH.J /13