


MASTER PLAN OF THQ HOSPITAL JAMPUR

PART 1

PART 2

PART 3

PART 4

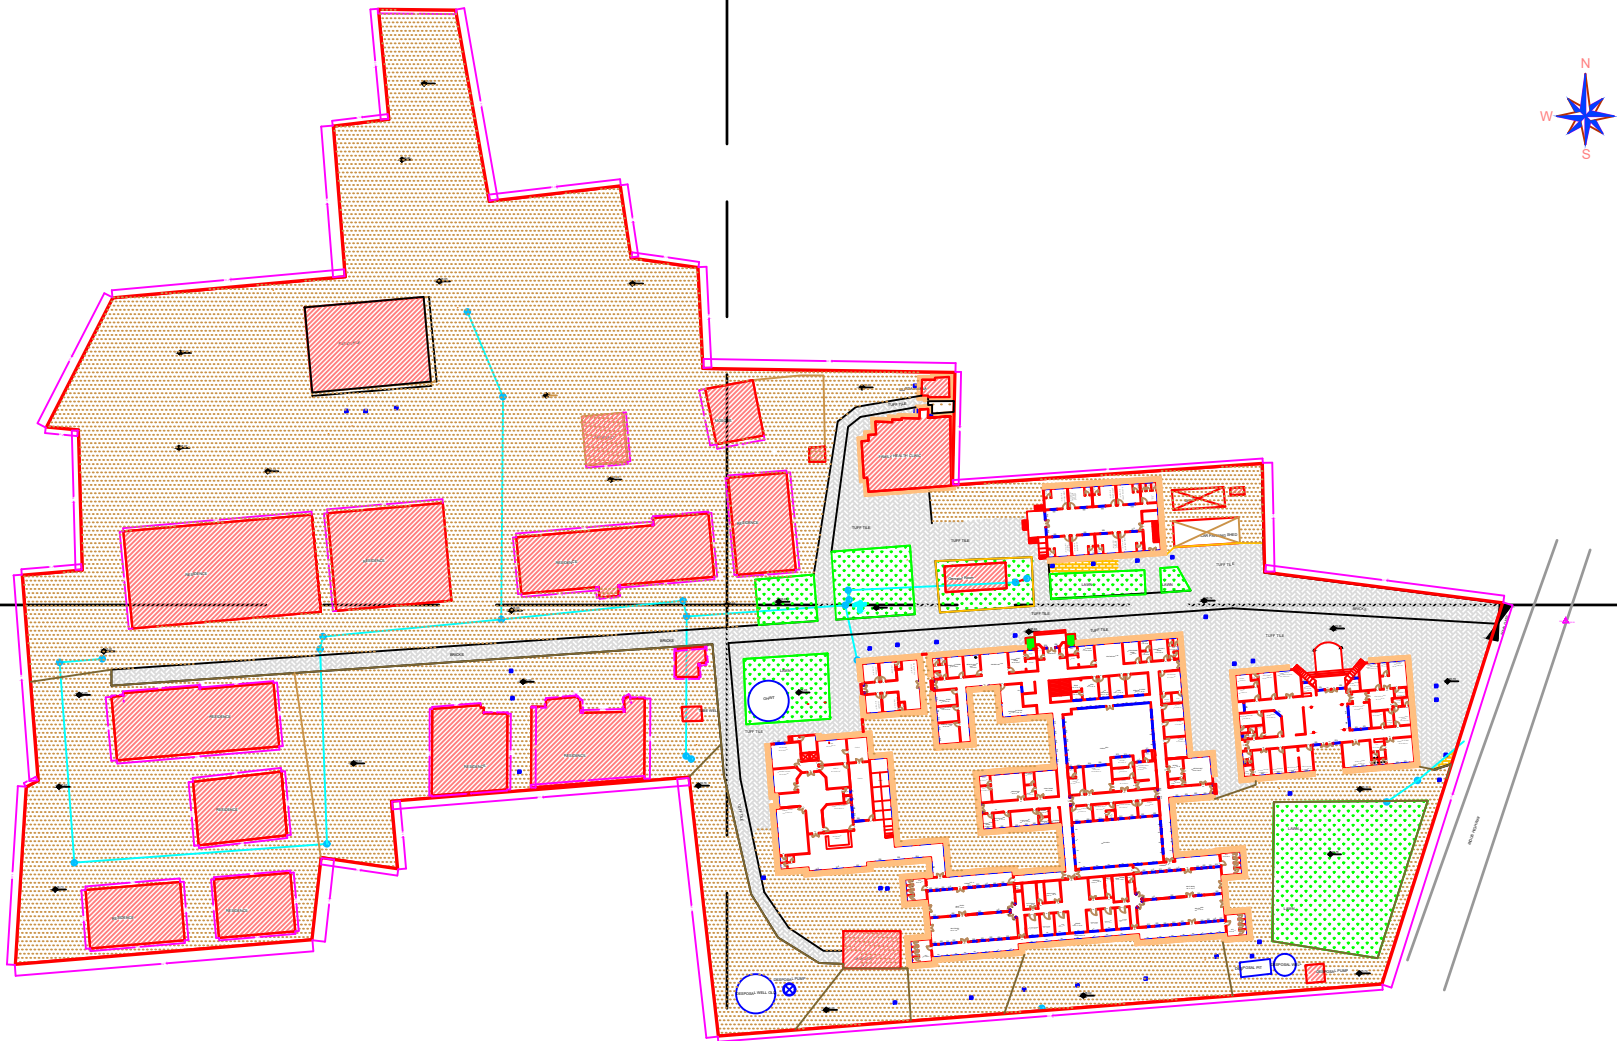

AREA WITHIN BOUNDARY
WALL=466530.23 SQ.FT.

Legends:

Residential Area	
Road	
Wall	
Power Line	
OHT	
Tree	
Man Hole	
Tube Well	
Light Pole	
Lawns	
Earthen Areas	
Asphalts Roads	
Tough Pavers	
P.C.C / Plinth Protection	
Boundary Wall	
Brick Pavers / Soling	
Drain	
Tap	
Hand Pump	
Air Conditioner	
Tube Light	
Fan	
Roof Light	
Bulb	

AREA	
AREA WITHIN BOUNDARY WALL	466530.23 Sft
AREA OF CLINICAL BLOCK	6999.9848 Sft
PLINTH AREA OF BLOCK	Sft

OPENING SCHEDULE OF DOORS AND WINDOWS					
DOORS	WIDTH	HEIGHT	WINDOWS	WIDTH	HEIGHT
D1	2'-6"	7'-0"	W1	2'-6"	2'-6"
D2	3'-0"	7'-0"	W2	3'-0"	3'-0"
D3	3'-6"	7'-0"	W3	4'-0"	4'-0"
D4	4'-0"	7'-0"	W4	5'-0"	5'-0"
D5	5'-0"	7'-0"	W5	6'-0"	6'-0"
D6	6'-0"	7'-0"	W6	8'-0"	8'-0"
D7	7'-0"	7'-0"	W7	9'-0"	9'-0"
D8	8'-0"	7'-0"	V1		
D9			V2		

Project:
**CAD MAPPING OF TEHSIL
HEAD QUARTER HOSPITALS,
PUNJAB**


Client: GOVERNMENT OF THE PUNJAB PRIMARY & SECONDARY HEALTHCARE DEPARTMENT	Consultant: SKAFS CONSULTANT (Pvt.) Limited ENGINEERING AND ENVIRONMENT CONSULTANT
---	--

Drawing Title: **THQ JAMPUR
HOSPITAL MASTER PLAN**

Drawing No. **SKAFS/JAMPUR /03**

MASTER PLAN OF THQ HOSPITAL JAMPUR

PART 1

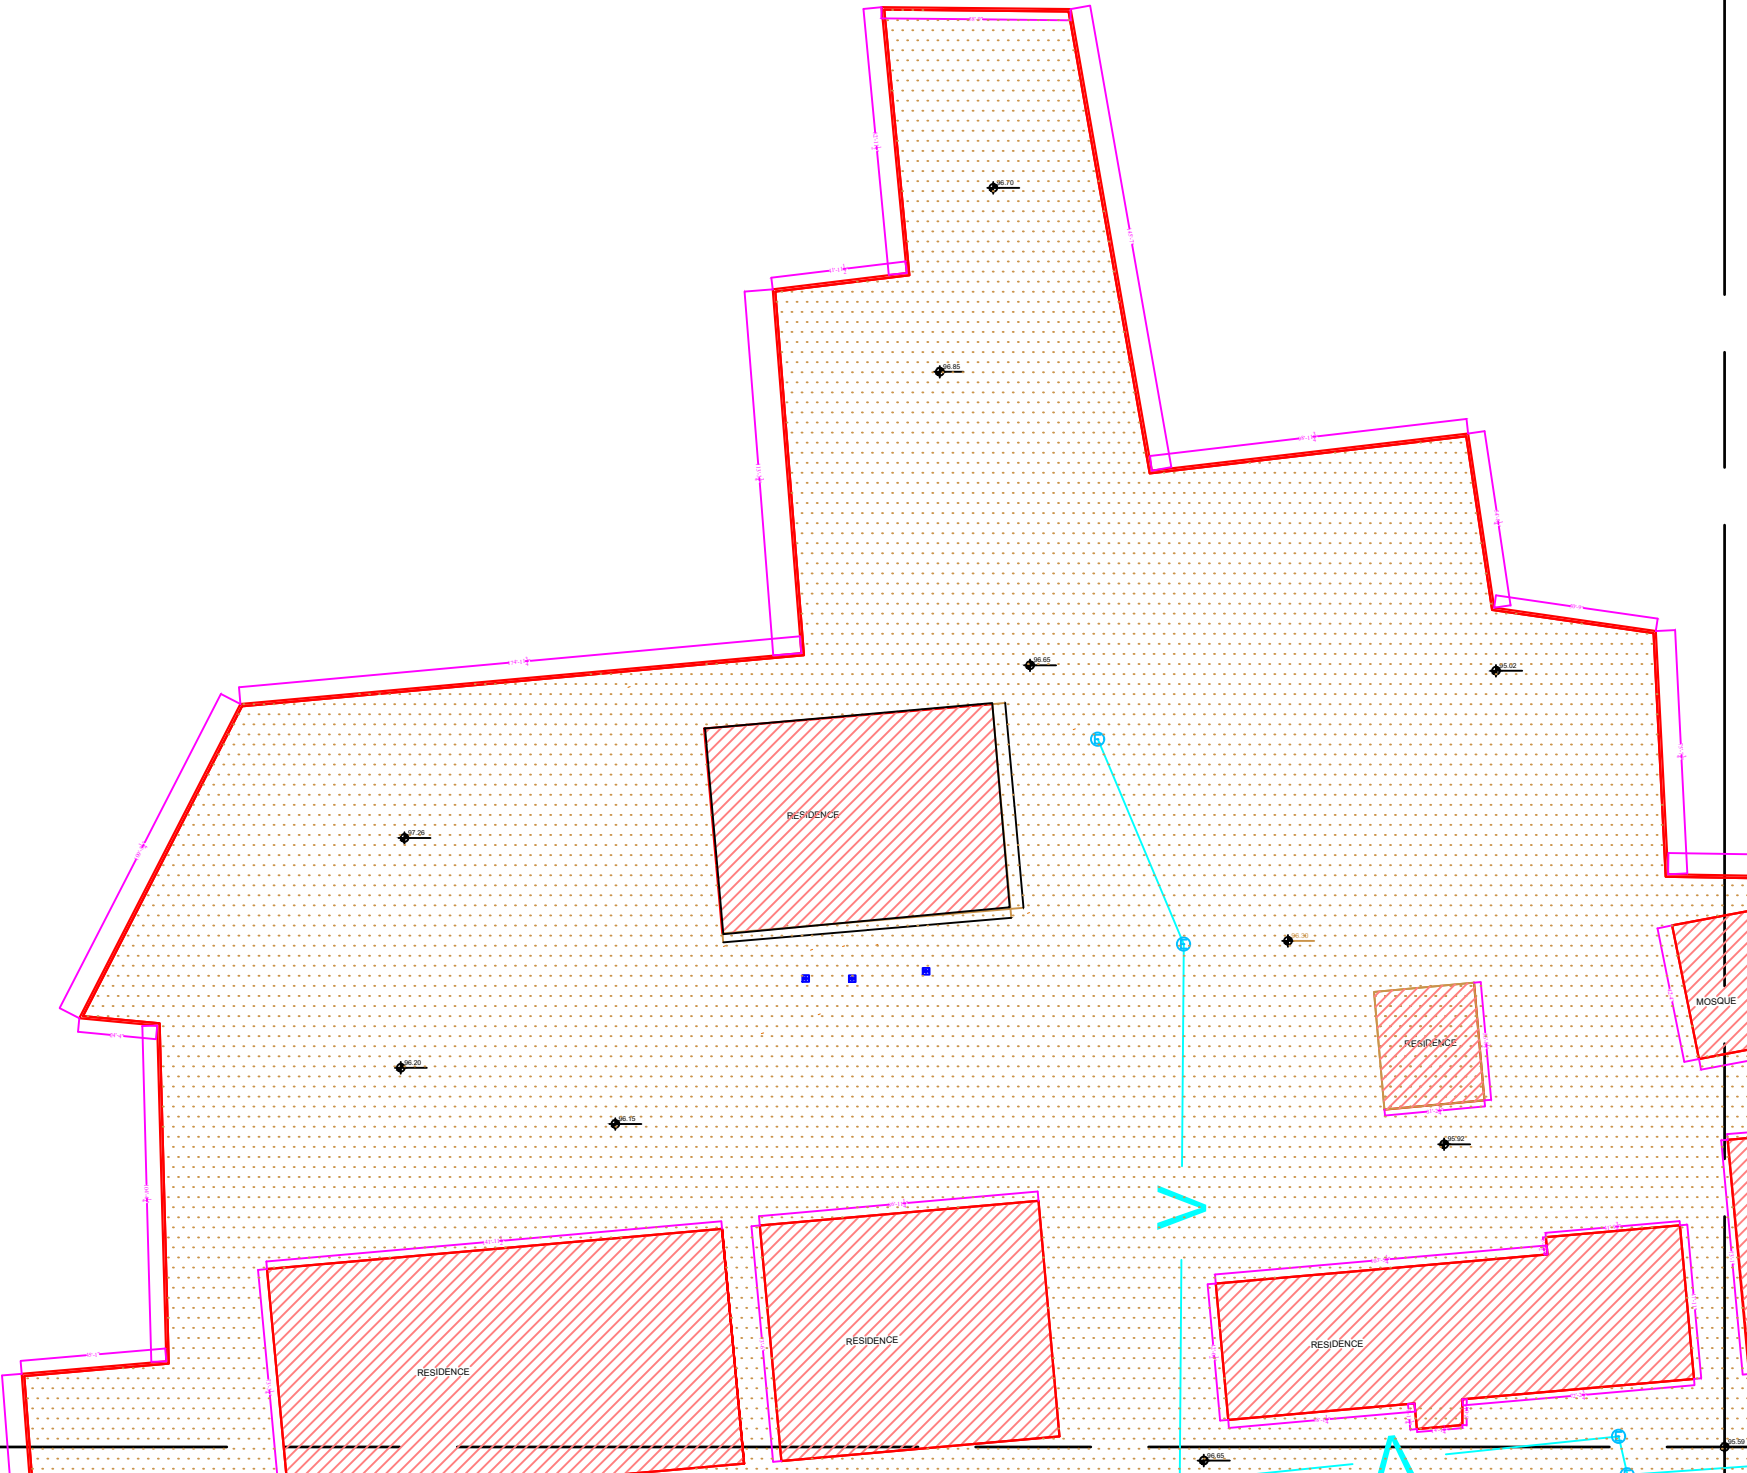

Legends:

Residential Area	
Road	
Wall	
Power Line	
OHT	
Tree	
Man Hole	
Tube Well	
Light Pole	
Lawns	
Earthen Areas	
Asphalts Roads	
Tough Pavers	
P.C.C / Plinth Protection	
Boundary Wall	
Brick Pavers / Soling	
Drain	
Tap	
Hand Pump	
Air Conditioner	
Tube Light	
Fan	
Roof Light	
Bulb	


AREA	
AREA WITHIN BOUNDARY WALL	466530.23 Sft
AREA OF CLINICAL BLOCK	6999.9848 Sft
PLINTH AREA OF BLOCK	Sft

OPENING SCHEDULE OF DOORS AND WINDOWS					
DOORS	WIDTH	HEIGHT	WINDOWS	WIDTH	HEIGHT
D1	2'-6"	7'-0"	W1	2'-6"	2'-6"
D2	3'-0"	7'-0"	W2	3'-0"	3'-0"
D3	3'-6"	7'-0"	W3	4'-0"	4'-0"
D4	4'-0"	7'-0"	W4	5'-0"	5'-0"
D5	5'-0"	7'-0"	W5	6'-0"	6'-0"
D6	6'-0"	7'-0"	W6	8'-0"	8'-0"
D7	7'-0"	7'-0"	W7	9'-0"	9'-0"
D8	8'-0"	7'-0"	V1		
D9			V2		

Project:	
CAD MAPPING OF TEHSIL HEAD QUARTER HOSPITALS, PUNJAB	
Client:	Consultant:
 GOVERNMENT OF THE PUNJAB PRIMARY & SECONDARY HEALTHCARE DEPARTMENT	 SKAFS CONSULTANT (Pvt.) Limited ENGINEERING AND ENVIRONMENT CONSULTANT
Drawing Title:	
THQ JAMPUR HOSPITAL MASTER PLAN PART 1	
Drawing No.	
SKAFS/JAMPUR /04	

MASTER PLAN OF THQ HOSPITAL JAMPUR

PART 2

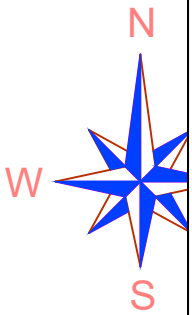

Legends:

Residential Area	
Road	
Wall	
Power Line	
OHT	
Tree	
Man Hole	
Tube Well	
Light Pole	
Lawns	
Earthen Areas	
Asphalts Roads	
Tough Pavers	
P.C.C / Plinth Protection	
Boundary Wall	
Brick Pavers / Soling	
Drain	
Tap	
Hand Pump	
Air Conditioner	
Tube Light	
Fan	
Roof Light	
Bulb	

AREA					
AREA WITHIN BOUNDARY WALL			466530.23 Sft		
AREA OF CLINICAL BLOCK			6999.9848 Sft		
PLINTH AREA OF BLOCK			Sft		
OPENING SCHEDULE OF DOORS AND WINDOWS					
DOORS	WIDTH	HEIGHT	WINDOWS	WIDTH	HEIGHT
D1	2'-6"	7'-0"	W1	2'-6"	2'-6"
D2	3'-0"	7'-0"	W2	3'-0"	3'-0"
D3	3'-6"	7'-0"	W3	4'-0"	4'-0"
D4	4'-0"	7'-0"	W4	5'-0"	5'-0"
D5	5'-0"	7'-0"	W5	6'-0"	6'-0"
D6	6'-0"	7'-0"	W6	8'-0"	8'-0"
D7	7'-0"	7'-0"	W7	9'-0"	9'-0"
D8	8'-0"	7'-0"	V1		
D9			V2		

Project:

CAD MAPPING OF TEHSIL
HEAD QUARTER HOSPITALS,
PUNJAB

Client:



GOVERNMENT OF THE PUNJAB
PRIMARY & SECONDARY
HEALTHCARE DEPARTMENT

Consultant:



SKAFS CONSULTANT (Pvt.)
Limited
ENGINEERING AND ENVIRONMENT
CONSULTANT

Drawing Title:

THQ JAMPUR
HOSPITAL MASTER PLAN PART 2


Drawing No.

SKAFS/JAMPUR /05



MASTER PLAN OF THQ HOSPITAL JAMPUR

PART 3

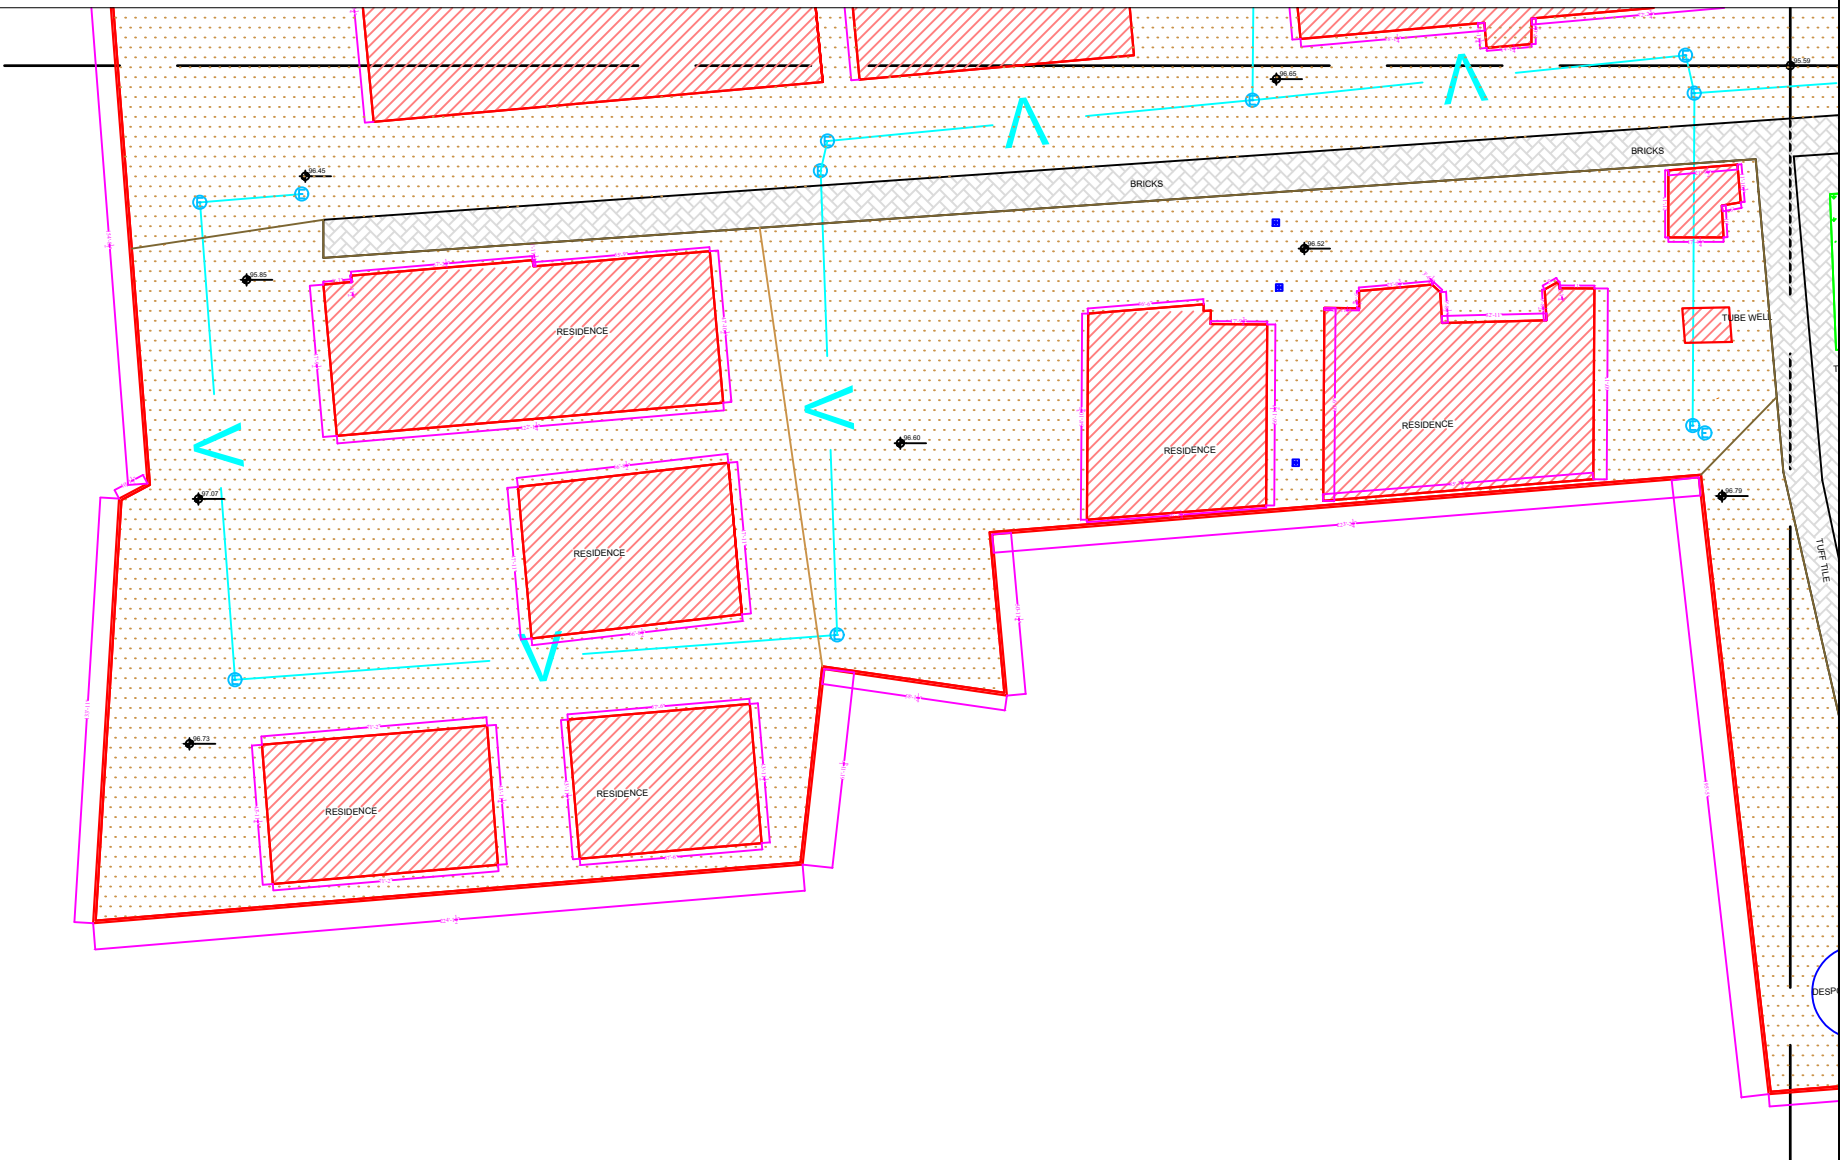

Legends:

Residential Area	
Road	
Wall	
Power Line	
OHT	
Tree	
Man Hole	
Tube Well	
Light Pole	
Lawns	
Earthen Areas	
Asphalts Roads	
Tough Pavers	
P.C.C / Plinth Protection	
Boundary Wall	
Brick Pavers / Soling	
Drain	
Tap	
Hand Pump	
Air Conditioner	
Tube Light	
Fan	
Roof Light	
Bulb	

AREA	
AREA WITHIN BOUNDARY WALL	466530.23 Sft
AREA OF CLINICAL BLOCK	6999.9848 Sft
PLINTH AREA OF BLOCK	Sft

OPENING SCHEDULE OF DOORS AND WINDOWS					
DOORS	WIDTH	HEIGHT	WINDOWS	WIDTH	HEIGHT
D1	2'-6"	7'-0"	W1	2'-6"	2'-6"
D2	3'-0"	7'-0"	W2	3'-0"	3'-0"
D3	3'-6"	7'-0"	W3	4'-0"	4'-0"
D4	4'-0"	7'-0"	W4	5'-0"	5'-0"
D5	5'-0"	7'-0"	W5	6'-0"	6'-0"
D6	6'-0"	7'-0"	W6	8'-0"	8'-0"
D7	7'-0"	7'-0"	W7	9'-0"	9'-0"
D8	8'-0"	7'-0"	V1		
D9			V2		

Project:
**CAD MAPPING OF TEHSIL
HEAD QUARTER HOSPITALS,
PUNJAB**


Client: GOVERNMENT OF THE PUNJAB PRIMARY & SECONDARY HEALTHCARE DEPARTMENT	Consultant: SKAFS CONSULTANT (Pvt.) Limited ENGINEERING AND ENVIRONMENT CONSULTANT
---	--

Drawing Title: **THQ JAMPUR
HOSPITAL MASTER PLAN PART 3**

Drawing No. **SKAFS/JAMPUR /06**

MASTER PLAN OF THQ HOSPITAL JAMPUR

PART 4

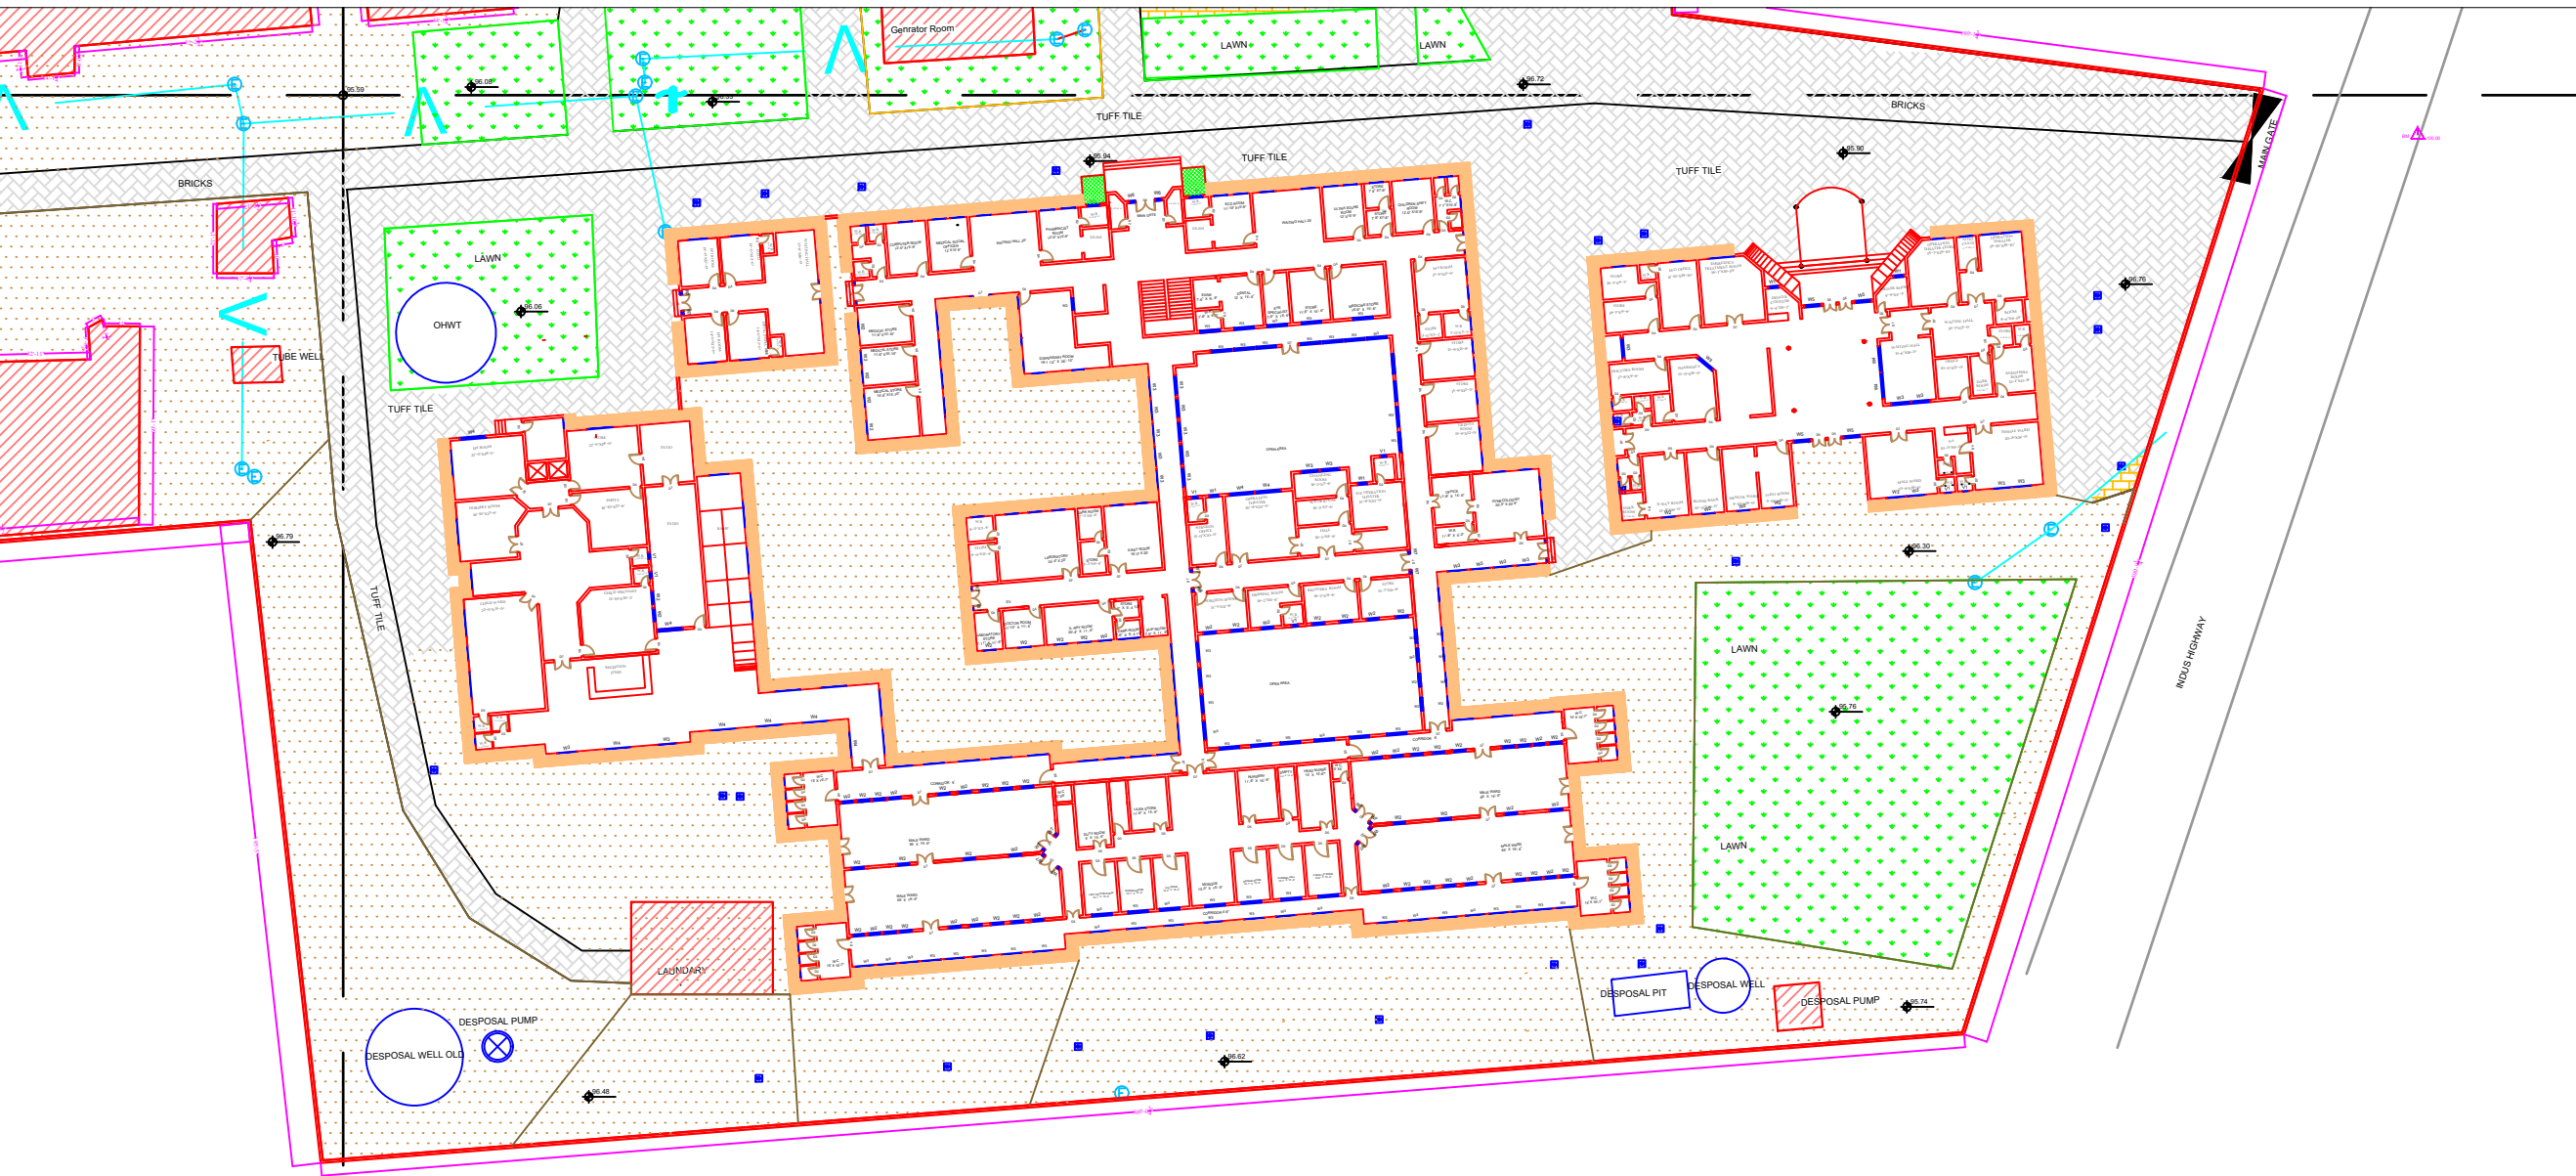

AREA WITHIN BOUNDARY
WALL=466530.23 SQ.FT.

Legends:

Residential Area	
Road	
Wall	
Power Line	
OHT	
Tree	
Man Hole	
Tube Well	
Light Pole	
Lawns	
Earthen Areas	
Asphalts Roads	
Tough Pavers	
P.C.C / Plinth Protection	
Boundary Wall	
Brick Pavers / Soling	
Drain	
Tap	
Hand Pump	
Air Conditioner	
Tube Light	
Fan	
Roof Light	
Bulb	

AREA	
AREA WITHIN BOUNDARY WALL	466530.23 Sft
AREA OF CLINICAL BLOCK	6999.9848 Sft
PLINTH AREA OF BLOCK	Sft

OPENING SCHEDULE OF DOORS AND WINDOWS					
DOORS	WIDTH	HEIGHT	WINDOWS	WIDTH	HEIGHT
D1	2'-6"	7'-0"	W1	2'-6"	2'-6"
D2	3'-0"	7'-0"	W2	3'-0"	3'-0"
D3	3'-6"	7'-0"	W3	4'-0"	4'-0"
D4	4'-0"	7'-0"	W4	5'-0"	5'-0"
D5	5'-0"	7'-0"	W5	6'-0"	6'-0"
D6	6'-0"	7'-0"	W6	8'-0"	8'-0"
D7	7'-0"	7'-0"	W7	9'-0"	9'-0"
D8	8'-0"	7'-0"	V1		
D9			V2		

Project:
**CAD MAPPING OF TEHSIL
HEAD QUARTER HOSPITALS,
PUNJAB**

Client: GOVERNMENT OF THE PUNJAB PRIMARY & SECONDARY HEALTHCARE DEPARTMENT	Consultant: SKAFS CONSULTANT (Pvt.) Limited ENGINEERING AND ENVIRONMENT CONSULTANT
---	--

Drawing Title: **THQ JAMPUR
HOSPITAL MASTER PLAN PART 4**

Drawing No. **SKAFS/JAMPUR /07**

CLINICAL BLOCK OF THQ HOSPITAL JAMPUR




GROUND FLOOR

PART 1

PART 2

PART 3

PART 4

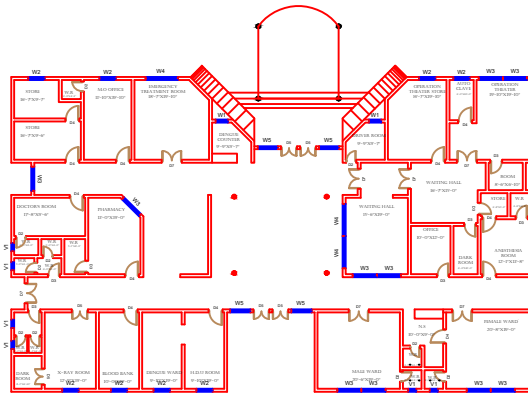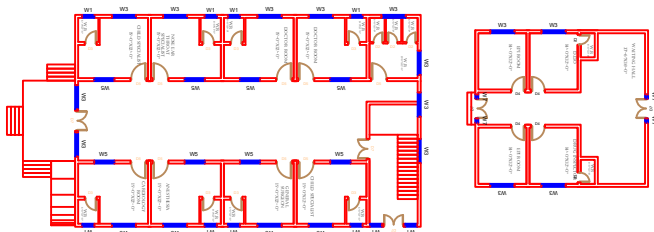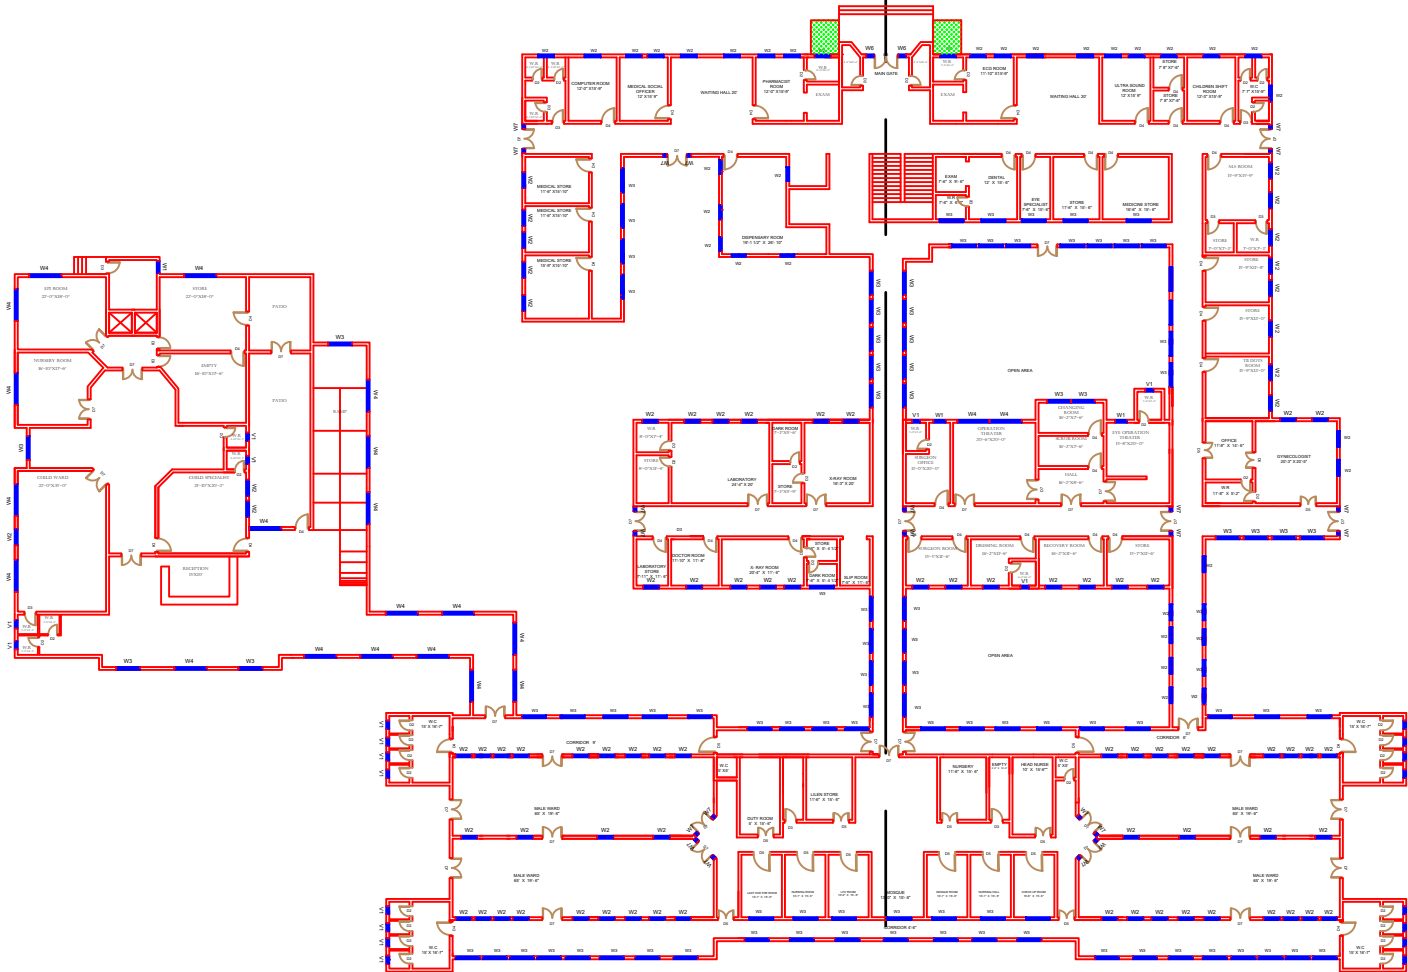

Legends:

Residential Area	
Road	
Wall	
Power Line	
OHT	
Tree	
Man Hole	
Tube Well	
Light Pole	
Lawns	
Earthen Areas	
Asphalts Roads	
Tough Pavers	
P.C.C / Plinth Protection	
Boundary Wall	
Brick Pavers / Soling	
Drain	
Tap	
Hand Pump	
Air Conditioner	
Tube Light	
Fan	
Roof Light	
Bulb	

AREA	
AREA WITHIN BOUNDARY WALL	466530.23 Sft
AREA OF CLINICAL BLOCK	6999.9848 Sft
PLINTH AREA OF BLOCK	Sft

OPENING SCHEDULE OF DOORS AND WINDOWS					
DOORS	WIDTH	HEIGHT	WINDOWS	WIDTH	HEIGHT
D1	2'-6"	7'-0"	W1	2'-6"	2'-6"
D2	3'-0"	7'-0"	W2	3'-0"	3'-0"
D3	3'-6"	7'-0"	W3	4'-0"	4'-0"
D4	4'-0"	7'-0"	W4	5'-0"	5'-0"
D5	5'-0"	7'-0"	W5	6'-0"	6'-0"
D6	6'-0"	7'-0"	W6	8'-0"	8'-0"
D7	7'-0"	7'-0"	W7	9'-0"	9'-0"
D8	8'-0"	7'-0"	V1		
D9			V2		

Project: CAD MAPPING OF TEHSIL HEAD QUARTER HOSPITALS, PUNJAB


Client:	Consultant:
 GOVERNMENT OF THE PUNJAB PRIMARY & SECONDARY HEALTHCARE DEPARTMENT	 SKAFS CONSULTANT (Pvt.) Limited ENGINEERING AND ENVIRONMENT CONSULTANT

Drawing Title: THQ JAMPUR HOSPITAL CLINICAL BLOCK PLAN

Drawing No. SKAFS/JAMPUR /08

CLINICAL BLOCK OF THQ HOSPITAL JAMPUR

GROUND FLOOR PART 1

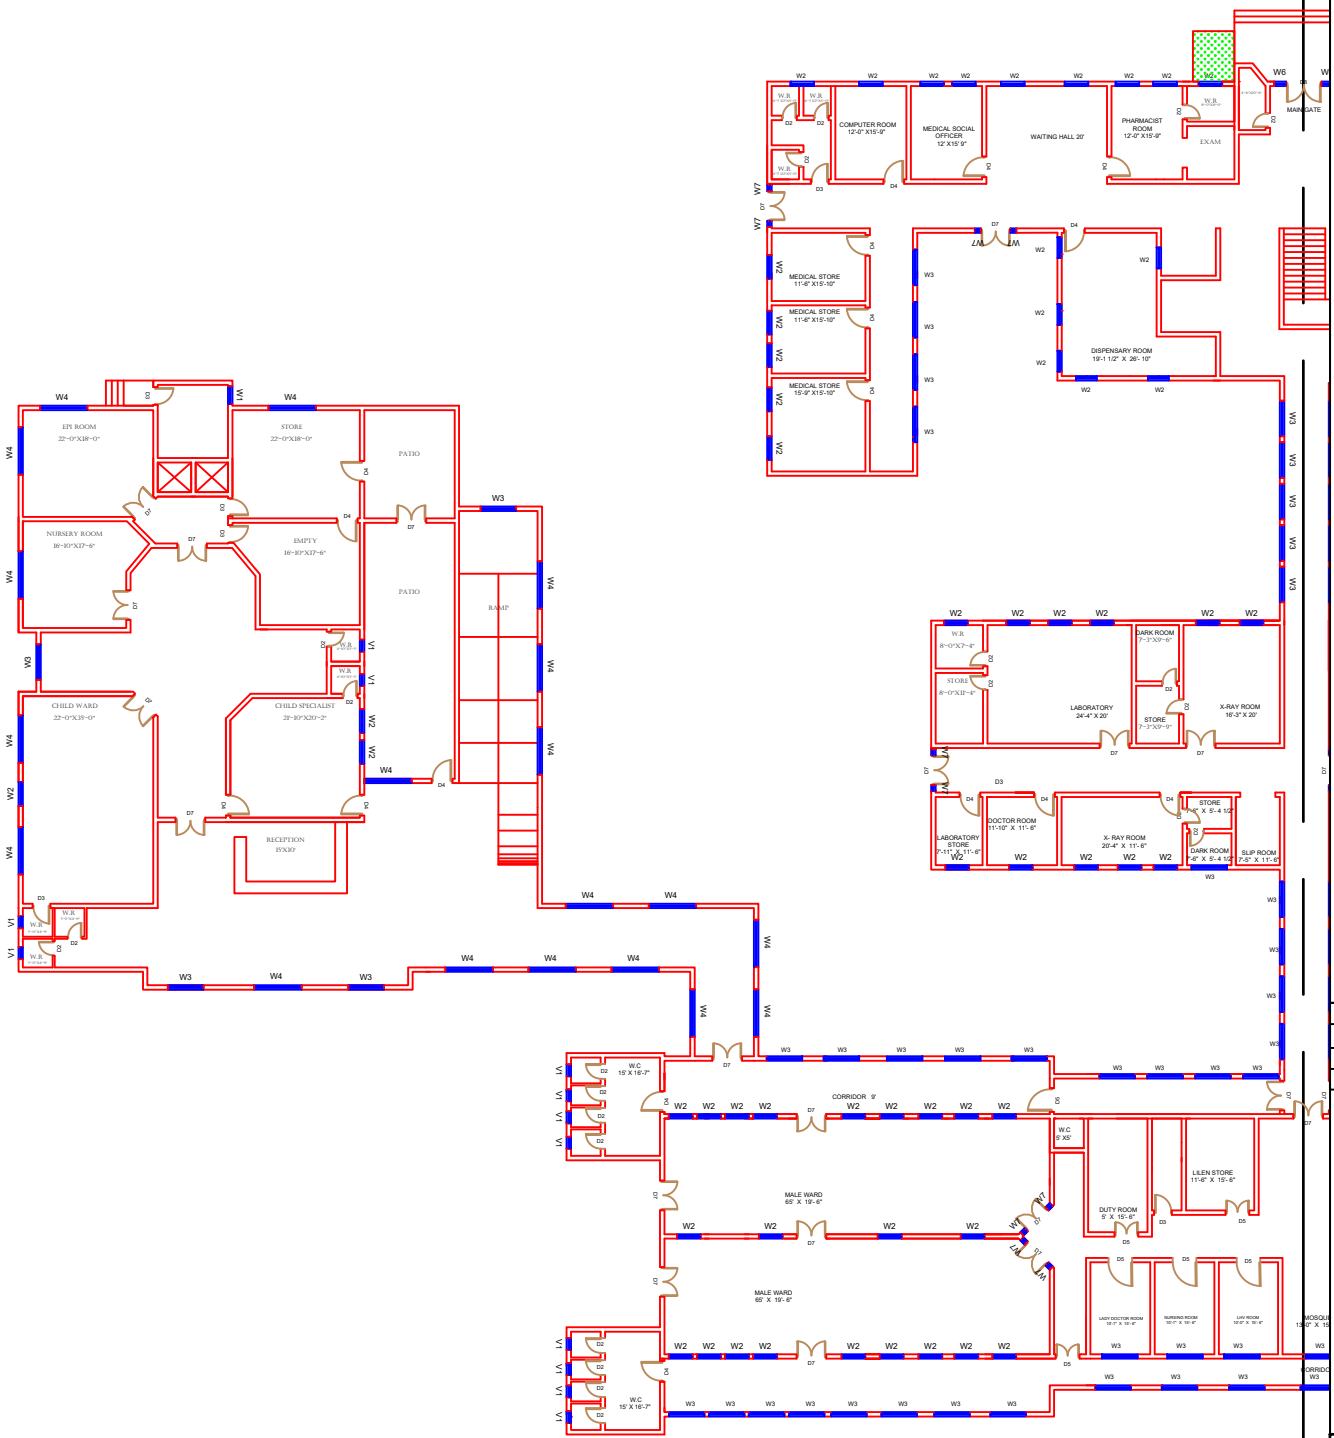

Legends:	
Residential Area	
Road	
Wall	
Power Line	
OHT	
Tree	
Man Hole	
Tube Well	
Light Pole	
Lawns	
Earthen Areas	
Asphalts Roads	
Tough Pavers	
P.C.C / Plinth Protection	
Boundary Wall	
Brick Pavers / Soling	
Drain	
Tap	
Hand Pump	
Air Conditioner	
Tube Light	
Fan	
Roof Light	
Bulb	

AREA	
AREA WITHIN BOUNDARY WALL	466530.23 Sft
AREA OF CLINICAL BLOCK	6999.9848 Sft
PLINTH AREA OF BLOCK	Sft

OPENING SCHEDULE OF DOORS AND WINDOWS					
DOORS	WIDTH	HEIGHT	WINDOWS	WIDTH	HEIGHT
D1	2'-6"	7'-0"	W1	2'-6"	2'-6"
D2	3'-0"	7'-0"	W2	3'-0"	3'-0"
D3	3'-6"	7'-0"	W3	4'-0"	4'-0"
D4	4'-0"	7'-0"	W4	5'-0"	5'-0"
D5	5'-0"	7'-0"	W5	6'-0"	6'-0"
D6	6'-0"	7'-0"	W6	8'-0"	8'-0"
D7	7'-0"	7'-0"	W7	9'-0"	9'-0"
D8	8'-0"	7'-0"	V1		
D9			V2		

Project:
**CAD MAPPING OF TEHSIL
HEAD QUARTER HOSPITALS,
PUNJAB**

Client:	Consultant:
 GOVERNMENT OF THE PUNJAB PRIMARY & SECONDARY HEALTHCARE DEPARTMENT	 SKAFS CONSULTANT (Pvt.) Limited ENGINEERING AND ENVIRONMENT CONSULTANT

Drawing Title:
**THQ JAMPUR
CLINICAL BLOCK PLAN (PART 1)**

Drawing No.
SKAFS/JAMPUR /09

The floor plan illustrates a comprehensive hospital layout. Key areas include:

- Entrance & Reception:** MAIN GATE, WAITING HALL 30'.
- Diagnostic & Treatment Rooms:** ECG ROOM (11'-10" X 13'-0"), ULTRA SOUND ROOM (12' X 13'-0"), STORE (7'-0" X 7'-0"), LASER ROOM (7'-0" X 7'-0"), CHILDREN SHFT ROOM (12' X 13'-0").
- Examination & Procedure Rooms:** EXAM (7'-0" X 9'-0"), DENTAL (12' X 15'-0"), EYE OPERATOR (7'-0" X 15'-0"), STORE (11'-0" X 15'-0"), MEDICINE STORE (10'-0" X 15'-0").
- Specialized Clinics:** GYNECOLOGIST (20'-0" X 20'-0"), OPHTHALMOLOGIST (11'-0" X 14'-0").
- Support & Service Areas:** CLEANING ROOM (10'-0" X 10'-0"), EYE OPERATOR (11'-0" X 15'-0"), EYE OPERATOR (11'-0" X 15'-0"), EYE OPERATOR (11'-0" X 15'-0").
- Recovery & Rest Areas:** RECOVERY ROOM (10'-0" X 15'-0"), DRESSING ROOM (11'-0" X 15'-0").
- Wards & Patient Care:** MALE WARD (20' X 15'-0"), MALE WARD (20' X 15'-0").
- Other Rooms:** NURSERY (11'-0" X 15'-0"), EMPTY (11'-0" X 15'-0"), HEAD NURSE (12' X 15'-0"), STORE (11'-0" X 15'-0").
- Corridors & Open Areas:** CORRIDOR 6'-0", OPEN AREA.

The plan uses red lines for room boundaries and blue lines for corridors. Various symbols and codes (e.g., W1, W2, W3, W99, W100) are used to identify specific rooms and corridors.

Residential Area	
Road	
Wall	
Power Line	
OHT	
Tree	
Man Hole	
Tube Well	
Light Pole	
Lawns	
Earthen Areas	
Asphalts Roads	
Tough Pavers	
P.C.C / Plinth Protection	
Boundary Wall	
Brick Pavers / Soling	
Drain	
Tap	
Hand Pump	
Air Conditioner	
Tube Light	
Fan	
Roof Light	
Bulb	

AREA	
AREA WITHIN BOUNDARY WALL	466530.23 Sft
AREA OF CLINICAL BLOCK	6999.9848 Sft
PLINTH AREA OF BLOCK	Sft

OPENING SCHEDULE OF DOORS AND WINDOWS					
DOORS	WIDTH	HEIGHT	WINDOWS	WIDTH	HEIGHT
D1	2'-6"	7'-0"	W1	2'-6"	2'-6"
D2	3'-0"	7'-0"	W2	3'-0"	3'-0"
D3	3'-6"	7'-0"	W3	4'-0"	4'-0"
D4	4'-0"	7'-0"	W4	5'-0"	5'-0"
D5	5'-0"	7'-0"	W5	6'-0"	6'-0"
D6	6'-0"	7'-0"	W6	8'-0"	8'-0"
D7	7'-0"	7'-0"	W7	9'-0"	9'-0"
D8	8'-0"	7'-0"	V1		
D9			V2		

Project:
**CAD MAPPING OF TEHSIL
HEAD QUARTER HOSPITALS,
PUNJAB**


Client:  GOVERNMENT OF THE PUNJAB PRIMARY & SECONDARY HEALTHCARE DEPARTMENT	Consultant:  SKAFS CONSULTANT (Pvt.) Limited <i>ENGINEERING AND ENVIRONMENT CONSULTANT</i>
--	---

Drawing Title: **THQ JAMPUR
CLINICAL BLOCK PLAN (PART 2)**

Drawing No. **SKAFS/JAMPUR /10**

CLINICAL BLOCK OF THQ HOSPITAL JAMPUR

GROUND FLOOR PART 3

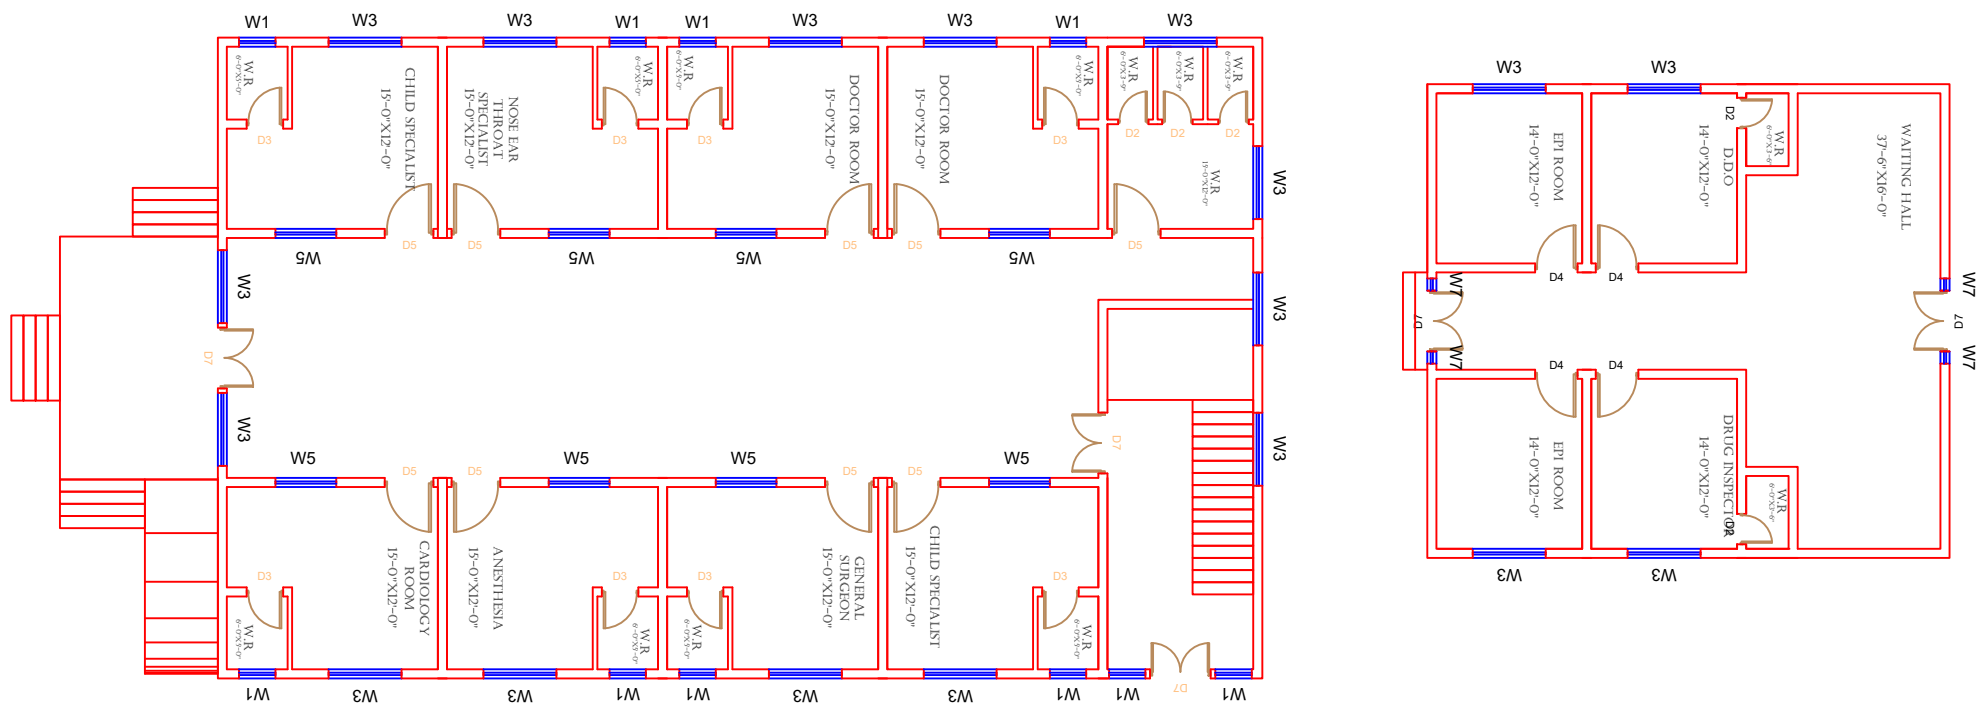

Legends:

Residential Area	
Road	
Wall	
Power Line	
OHT	
Tree	
Man Hole	
Tube Well	
Light Pole	
Lawns	
Earthen Areas	
Asphalts Roads	
Tough Pavers	
P.C.C / Plinth Protection	
Boundary Wall	
Brick Pavers / Soling	
Drain	
Tap	
Hand Pump	
Air Conditioner	
Tube Light	
Fan	
Roof Light	
Bulb	

AREA

AREA WITHIN BOUNDARY WALL	466530.23 Sft
AREA OF CLINICAL BLOCK	6999.9848 Sft
PLINTH AREA OF BLOCK	Sft

OPENING SCHEDULE OF DOORS AND WINDOWS

DOORS	WIDTH	HEIGHT	WINDOWS	WIDTH	HEIGHT
D1	2'-6"	7'-0"	W1	2'-6"	2'-6"
D2	3'-0"	7'-0"	W2	3'-0"	3'-0"
D3	3'-6"	7'-0"	W3	4'-0"	4'-0"
D4	4'-0"	7'-0"	W4	5'-0"	5'-0"
D5	5'-0"	7'-0"	W5	6'-0"	6'-0"
D6	6'-0"	7'-0"	W6	8'-0"	8'-0"
D7	7'-0"	7'-0"	W7	9'-0"	9'-0"
D8	8'-0"	7'-0"	V1		
D9			V2		

Project:
**CAD MAPPING OF TEHSIL
HEAD QUARTER HOSPITALS,
PUNJAB**

Client:



Consultant:




Drawing Title:
**THQ JAMPUR
CLINICAL BLOCK PLAN (PART 3)**

Drawing No.
SKAFS/JAMPUR /11

CLINICAL BLOCK OF THQ HOSPITAL JAMPUR

GROUND FLOOR PART 4

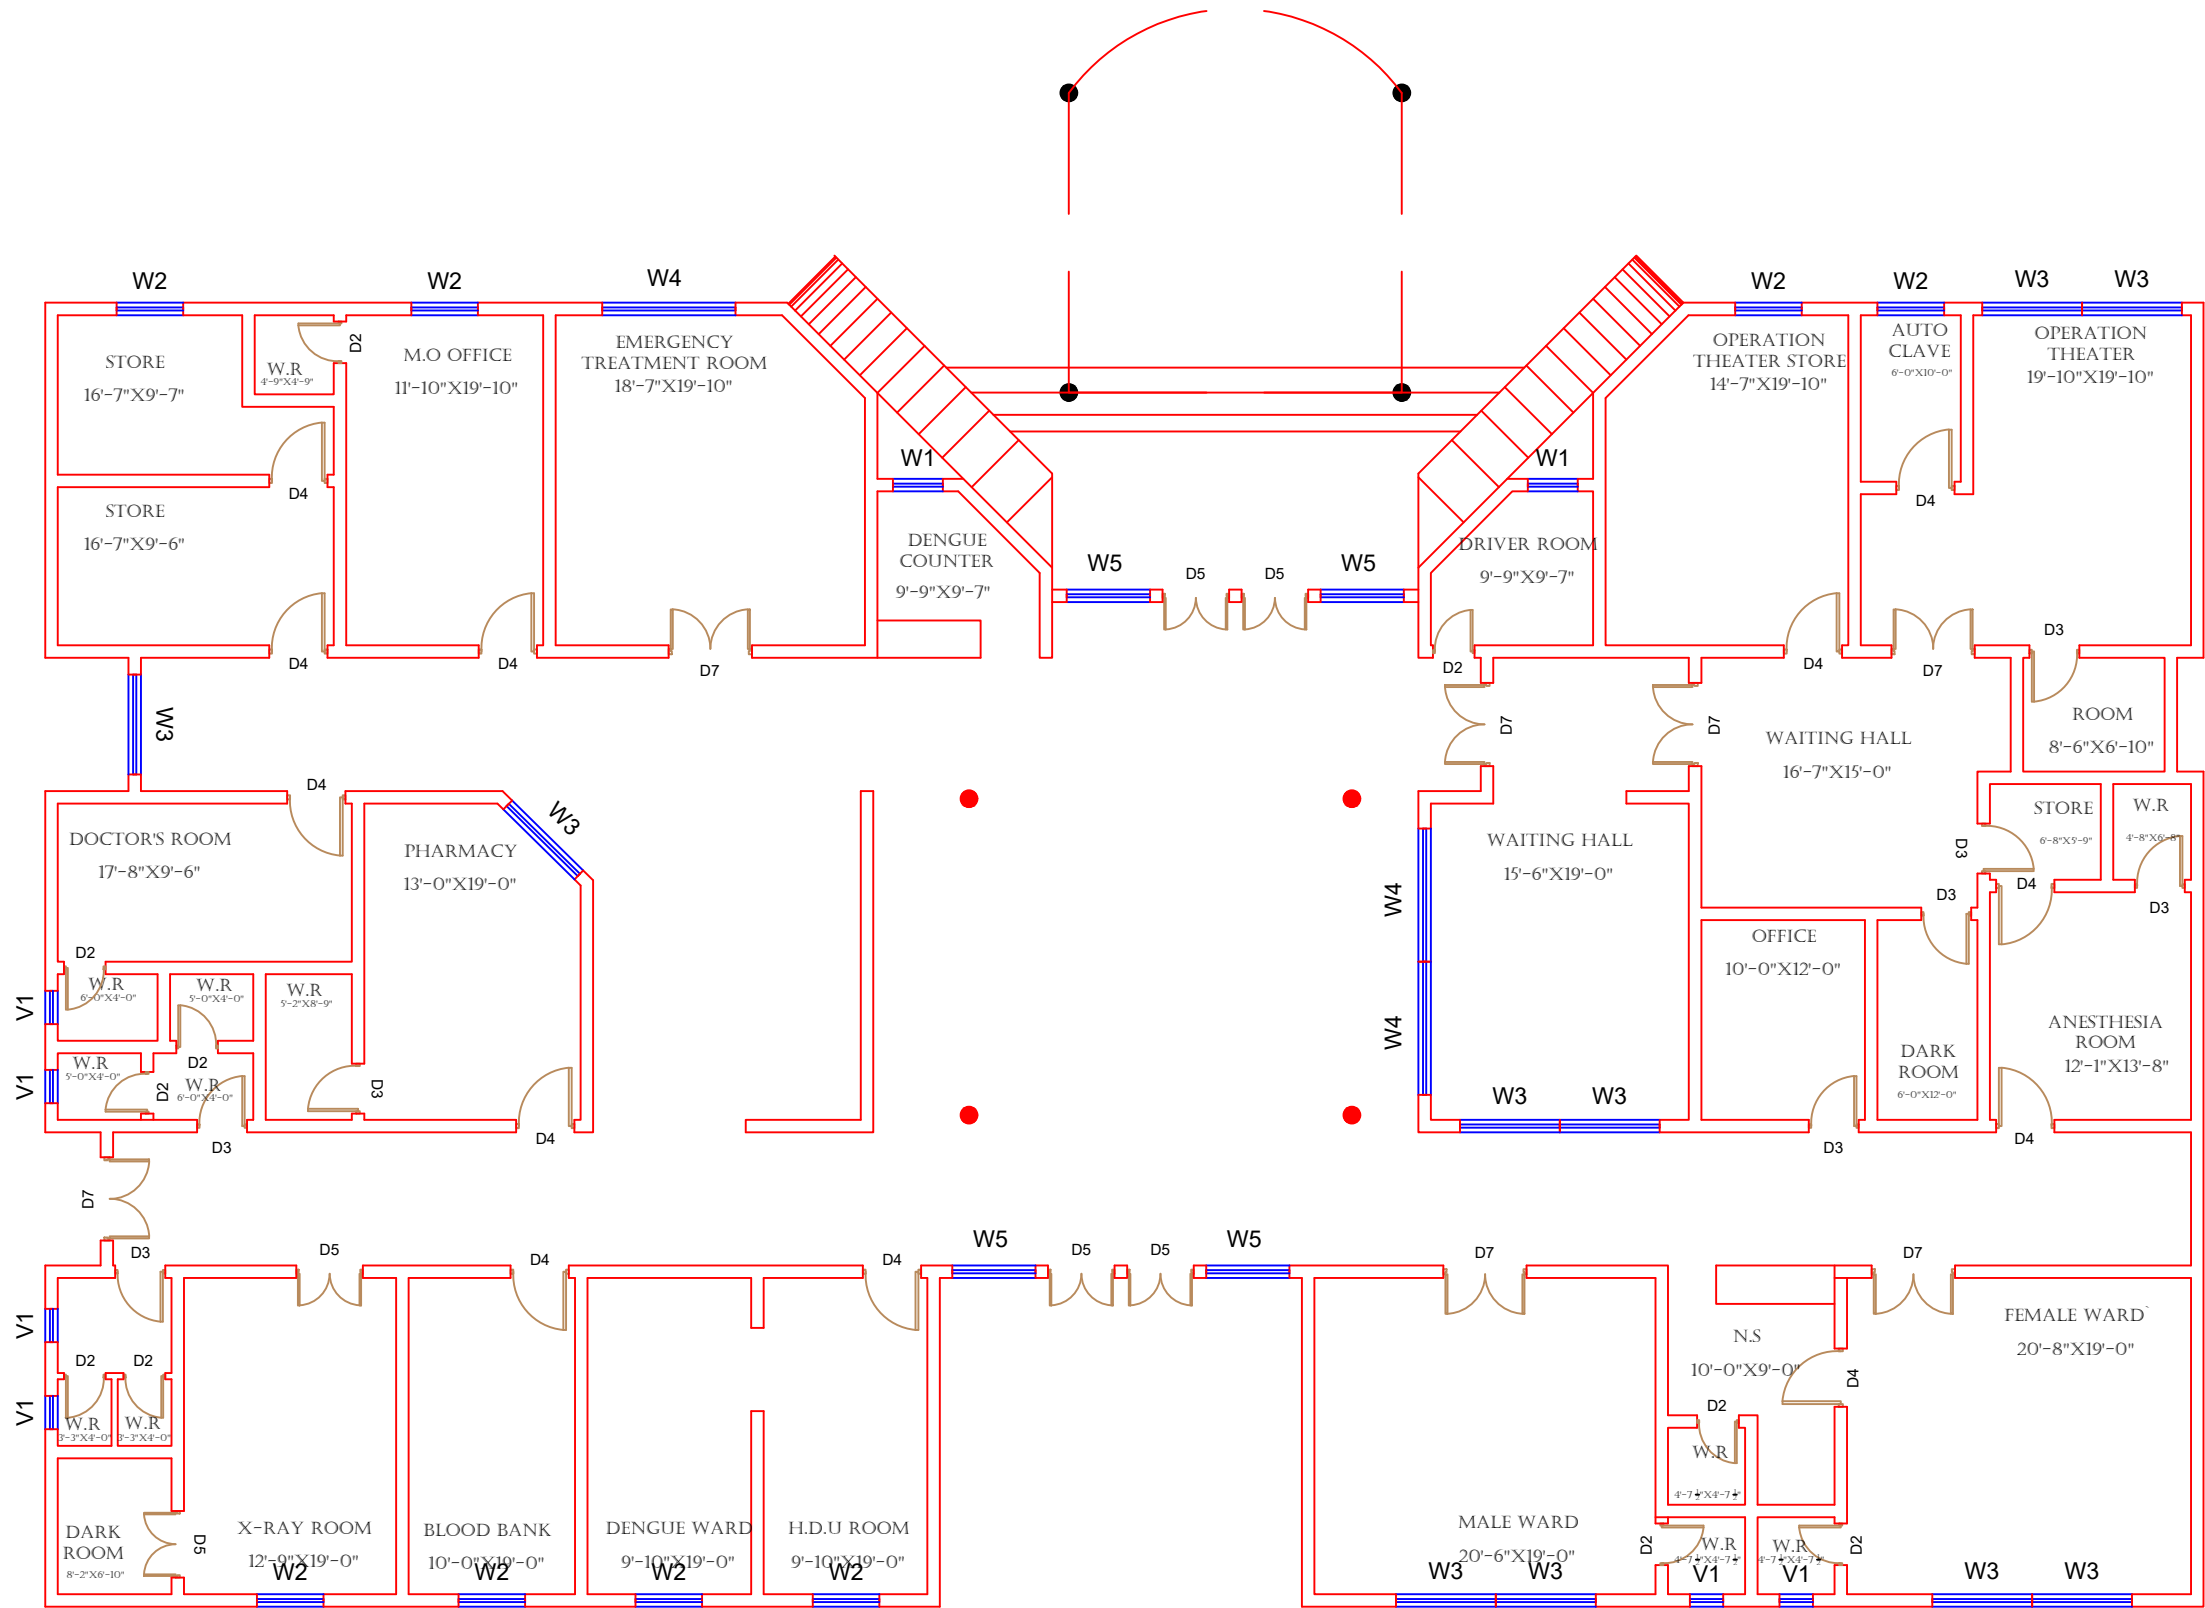

Legends:	
Residential Area	
Road	
Wall	
Power Line	
OHT	
Tree	
Man Hole	
Tube Well	
Light Pole	
Lawns	
Earthen Areas	
Asphalts Roads	
Tough Pavers	
P.C.C / Plinth Protection	
Boundary Wall	
Brick Pavers / Soling	
Drain	
Tap	
Hand Pump	
Air Conditioner	
Tube Light	
Fan	
Roof Light	
Bulb	


AREA	
AREA WITHIN BOUNDARY WALL	466530.23 Sft
AREA OF CLINICAL BLOCK	6999.9848 Sft
PLINTH AREA OF BLOCK	Sft

OPENING SCHEDULE OF DOORS AND WINDOWS					
DOORS	WIDTH	HEIGHT	WINDOWS	WIDTH	HEIGHT
D1	2'-6"	7'-0"	W1	2'-6"	2'-6"
D2	3'-0"	7'-0"	W2	3'-0"	3'-0"
D3	3'-6"	7'-0"	W3	4'-0"	4'-0"
D4	4'-0"	7'-0"	W4	5'-0"	5'-0"
D5	5'-0"	7'-0"	W5	6'-0"	6'-0"
D6	6'-0"	7'-0"	W6	8'-0"	8'-0"
D7	7'-0"	7'-0"	W7	9'-0"	9'-0"
D8	8'-0"	7'-0"	V1		
D9			V2		

Project:	
CAD MAPPING OF TEHSIL HEAD QUARTER HOSPITALS, PUNJAB	
Client:	Consultant:
 GOVERNMENT OF THE PUNJAB PRIMARY & SECONDARY HEALTHCARE DEPARTMENT	 SKAFS CONSULTANT (Pvt.) Limited ENGINEERING AND ENVIRONMENT CONSULTANT
Drawing Title:	
THQ JAMPUR CLINICAL BLOCK PLAN (PART 4)	
Drawing No.	
SKAFS/JAMPUR /12	

CLINICAL BLOCK OF THQ HOSPITAL JAMPUR

FIRST FLOOR PART 1

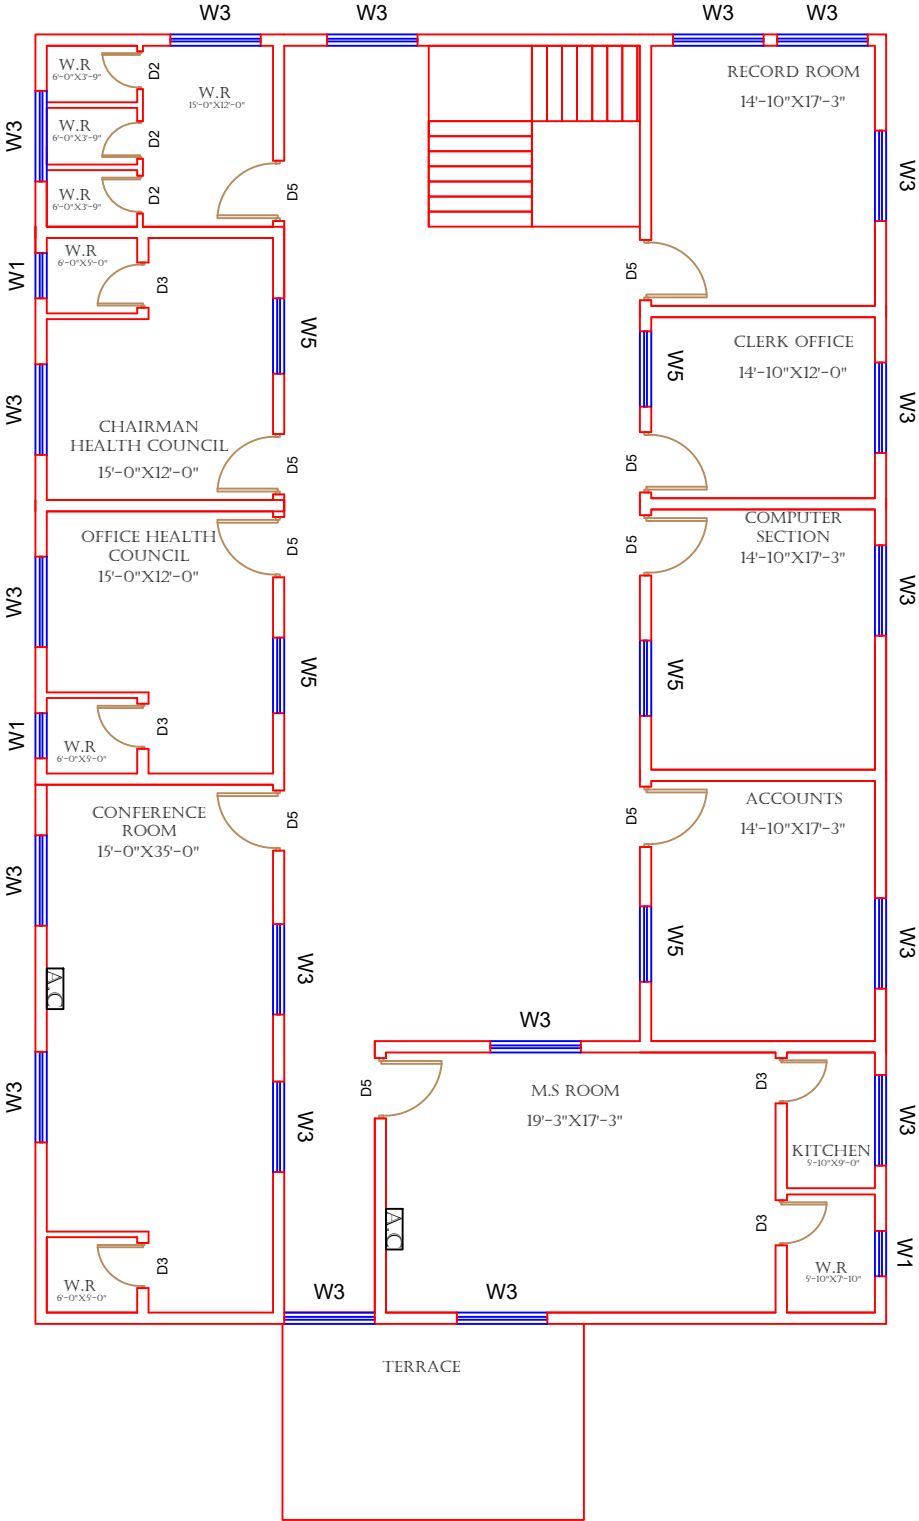

Legends:

Residential Area	
Road	
Wall	
Power Line	
OHT	
Tree	
Man Hole	
Tube Well	
Light Pole	
Lawns	
Earthen Areas	
Asphalts Roads	
Tough Pavers	
P.C.C / Plinth Protection	
Boundary Wall	
Brick Pavers / Soling	
Drain	
Tap	
Hand Pump	
Air Conditioner	
Tube Light	
Fan	
Roof Light	
Bulb	

AREA	
AREA WITHIN BOUNDARY WALL	466530.23 Sft
AREA OF CLINICAL BLOCK	6999.9848 Sft
PLINTH AREA OF BLOCK	Sft

OPENING SCHEDULE OF DOORS AND WINDOWS					
DOORS	WIDTH	HEIGHT	WINDOWS	WIDTH	HEIGHT
D1	2'-6"	7'-0"	W1	2'-6"	2'-6"
D2	3'-0"	7'-0"	W2	3'-0"	3'-0"
D3	3'-6"	7'-0"	W3	4'-0"	4'-0"
D4	4'-0"	7'-0"	W4	5'-0"	5'-0"
D5	5'-0"	7'-0"	W5	6'-0"	6'-0"
D6	6'-0"	7'-0"	W6	8'-0"	8'-0"
D7	7'-0"	7'-0"	W7	9'-0"	9'-0"
D8	8'-0"	7'-0"	V1		
D9			V2		

Project:
**CAD MAPPING OF TEHSIL
HEAD QUARTER HOSPITALS,
PUNJAB**

Client:

GOVERNMENT OF THE PUNJAB
PRIMARY & SECONDARY
HEALTHCARE DEPARTMENT

Consultant:


SKAFS CONSULTANT (Pvt.)
Limited
ENGINEERING AND ENVIRONMENT
CONSULTANT

Drawing Title:
**THQ JAMPUR
FIRST FLOOR PLAN (PART 1)**

Drawing No.
SKAFS/JAMPUR /13

CLINICAL BLOCK OF THQ HOSPITAL JAMPUR

FIRST FLOOR PART 2

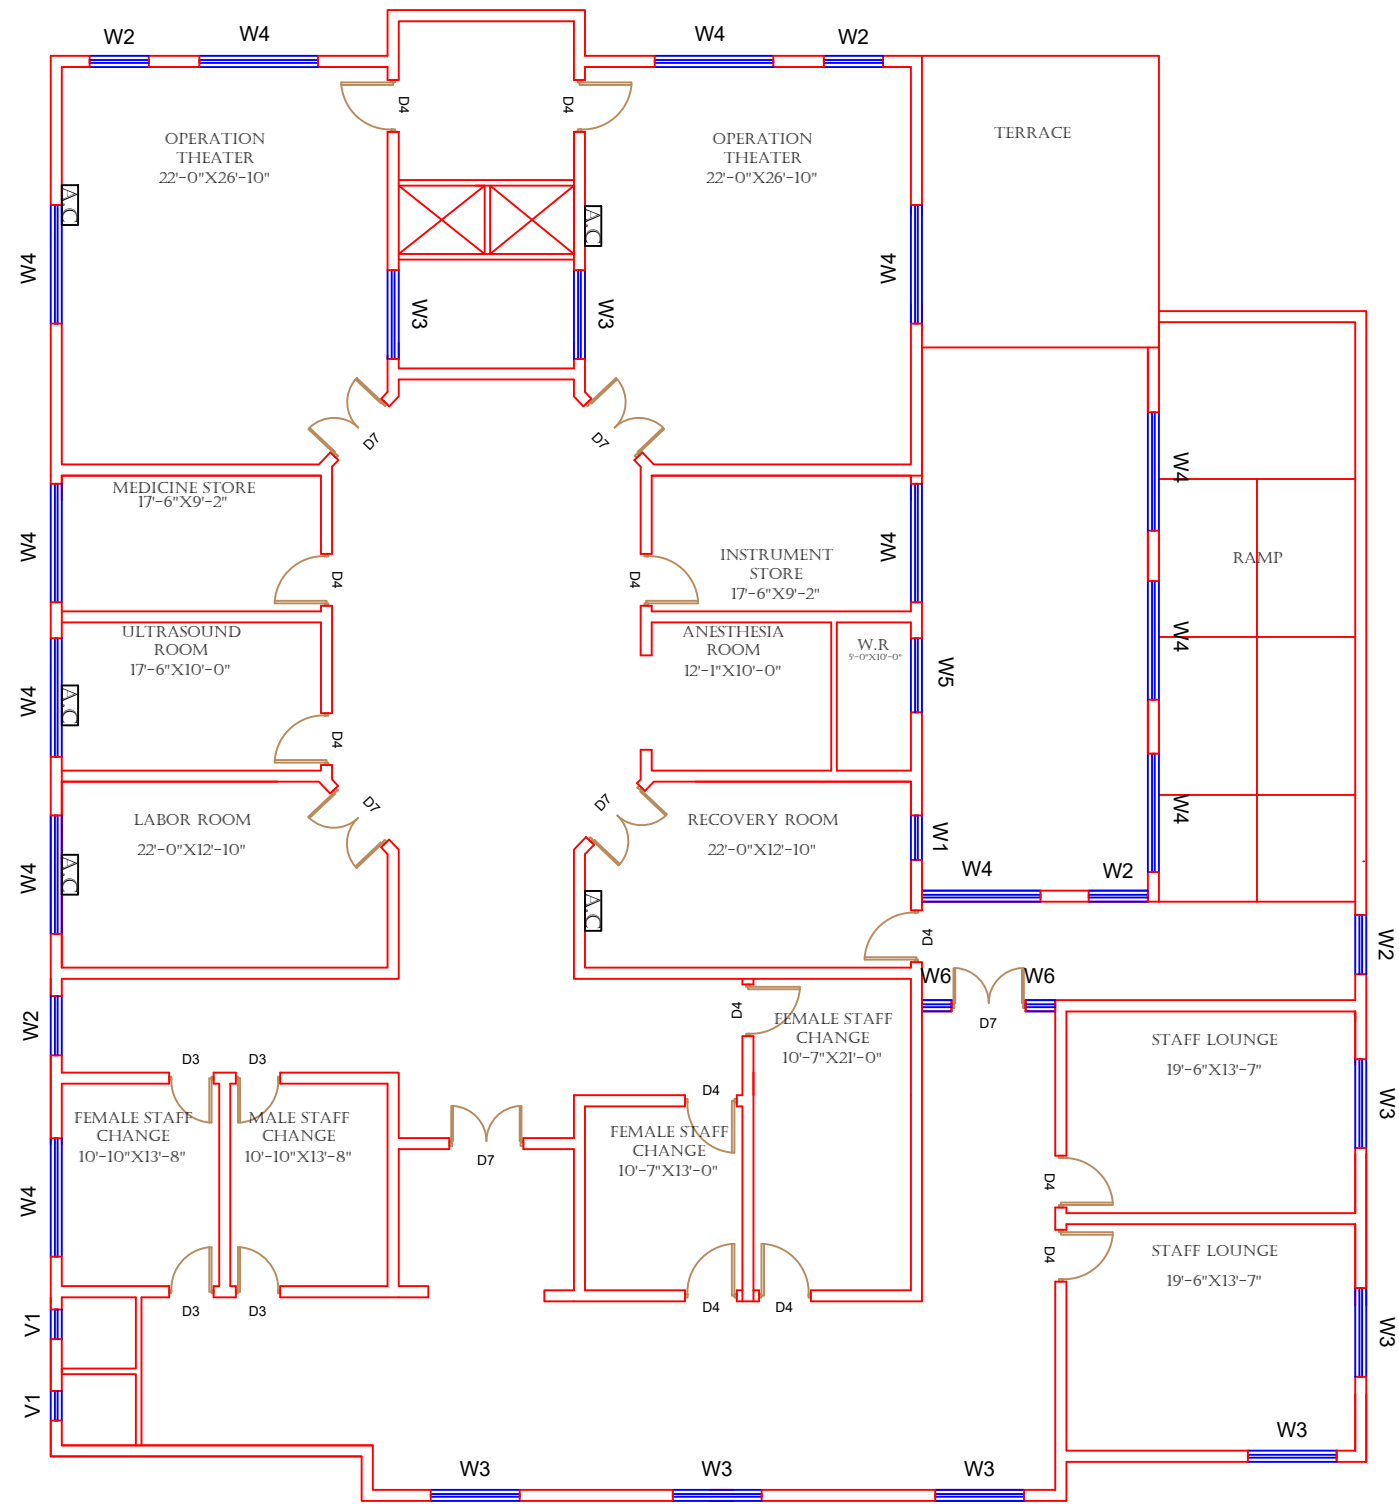

FIRST FLOOR

Legends:

Residential Area	
Road	
Wall	
Power Line	
OHT	
Tree	
Man Hole	
Tube Well	
Light Pole	
Lawns	
Earthen Areas	
Asphalts Roads	
Tough Pavers	
P.C.C / Plinth Protection	
Boundary Wall	
Brick Pavers / Soling	
Drain	
Tap	
Hand Pump	
Air Conditioner	
Tube Light	
Fan	
Roof Light	
Bulb	

AREA	
AREA WITHIN BOUNDARY WALL	466530.23 Sft
AREA OF CLINICAL BLOCK	6999.9848 Sft
PLINTH AREA OF BLOCK	Sft

OPENING SCHEDULE OF DOORS AND WINDOWS					
DOORS	WIDTH	HEIGHT	WINDOWS	WIDTH	HEIGHT
D1	2'-6"	7'-0"	W1	2'-6"	2'-6"
D2	3'-0"	7'-0"	W2	3'-0"	3'-0"
D3	3'-6"	7'-0"	W3	4'-0"	4'-0"
D4	4'-0"	7'-0"	W4	5'-0"	5'-0"
D5	5'-0"	7'-0"	W5	6'-0"	6'-0"
D6	6'-0"	7'-0"	W6	8'-0"	8'-0"
D7	7'-0"	7'-0"	W7	9'-0"	9'-0"
D8	8'-0"	7'-0"	V1		
D9			V2		

Project:
**CAD MAPPING OF TEHSIL
HEAD QUARTER HOSPITALS,
PUNJAB**

Client:

GOVERNMENT OF THE PUNJAB
PRIMARY & SECONDARY
HEALTHCARE DEPARTMENT

Consultant:


SKAFS CONSULTANT (Pvt.)
Limited
ENGINEERING AND ENVIRONMENT
CONSULTANT

Drawing Title:
**THQ JAMPUR
FIRST FLOOR PLAN (PART 2)**

Drawing No.
SKAFS/JAMPUR /14

ELECTRICAL LAYOUT PLAN OF THQ HOSPITAL JAMPUR

GROUND FLOOR

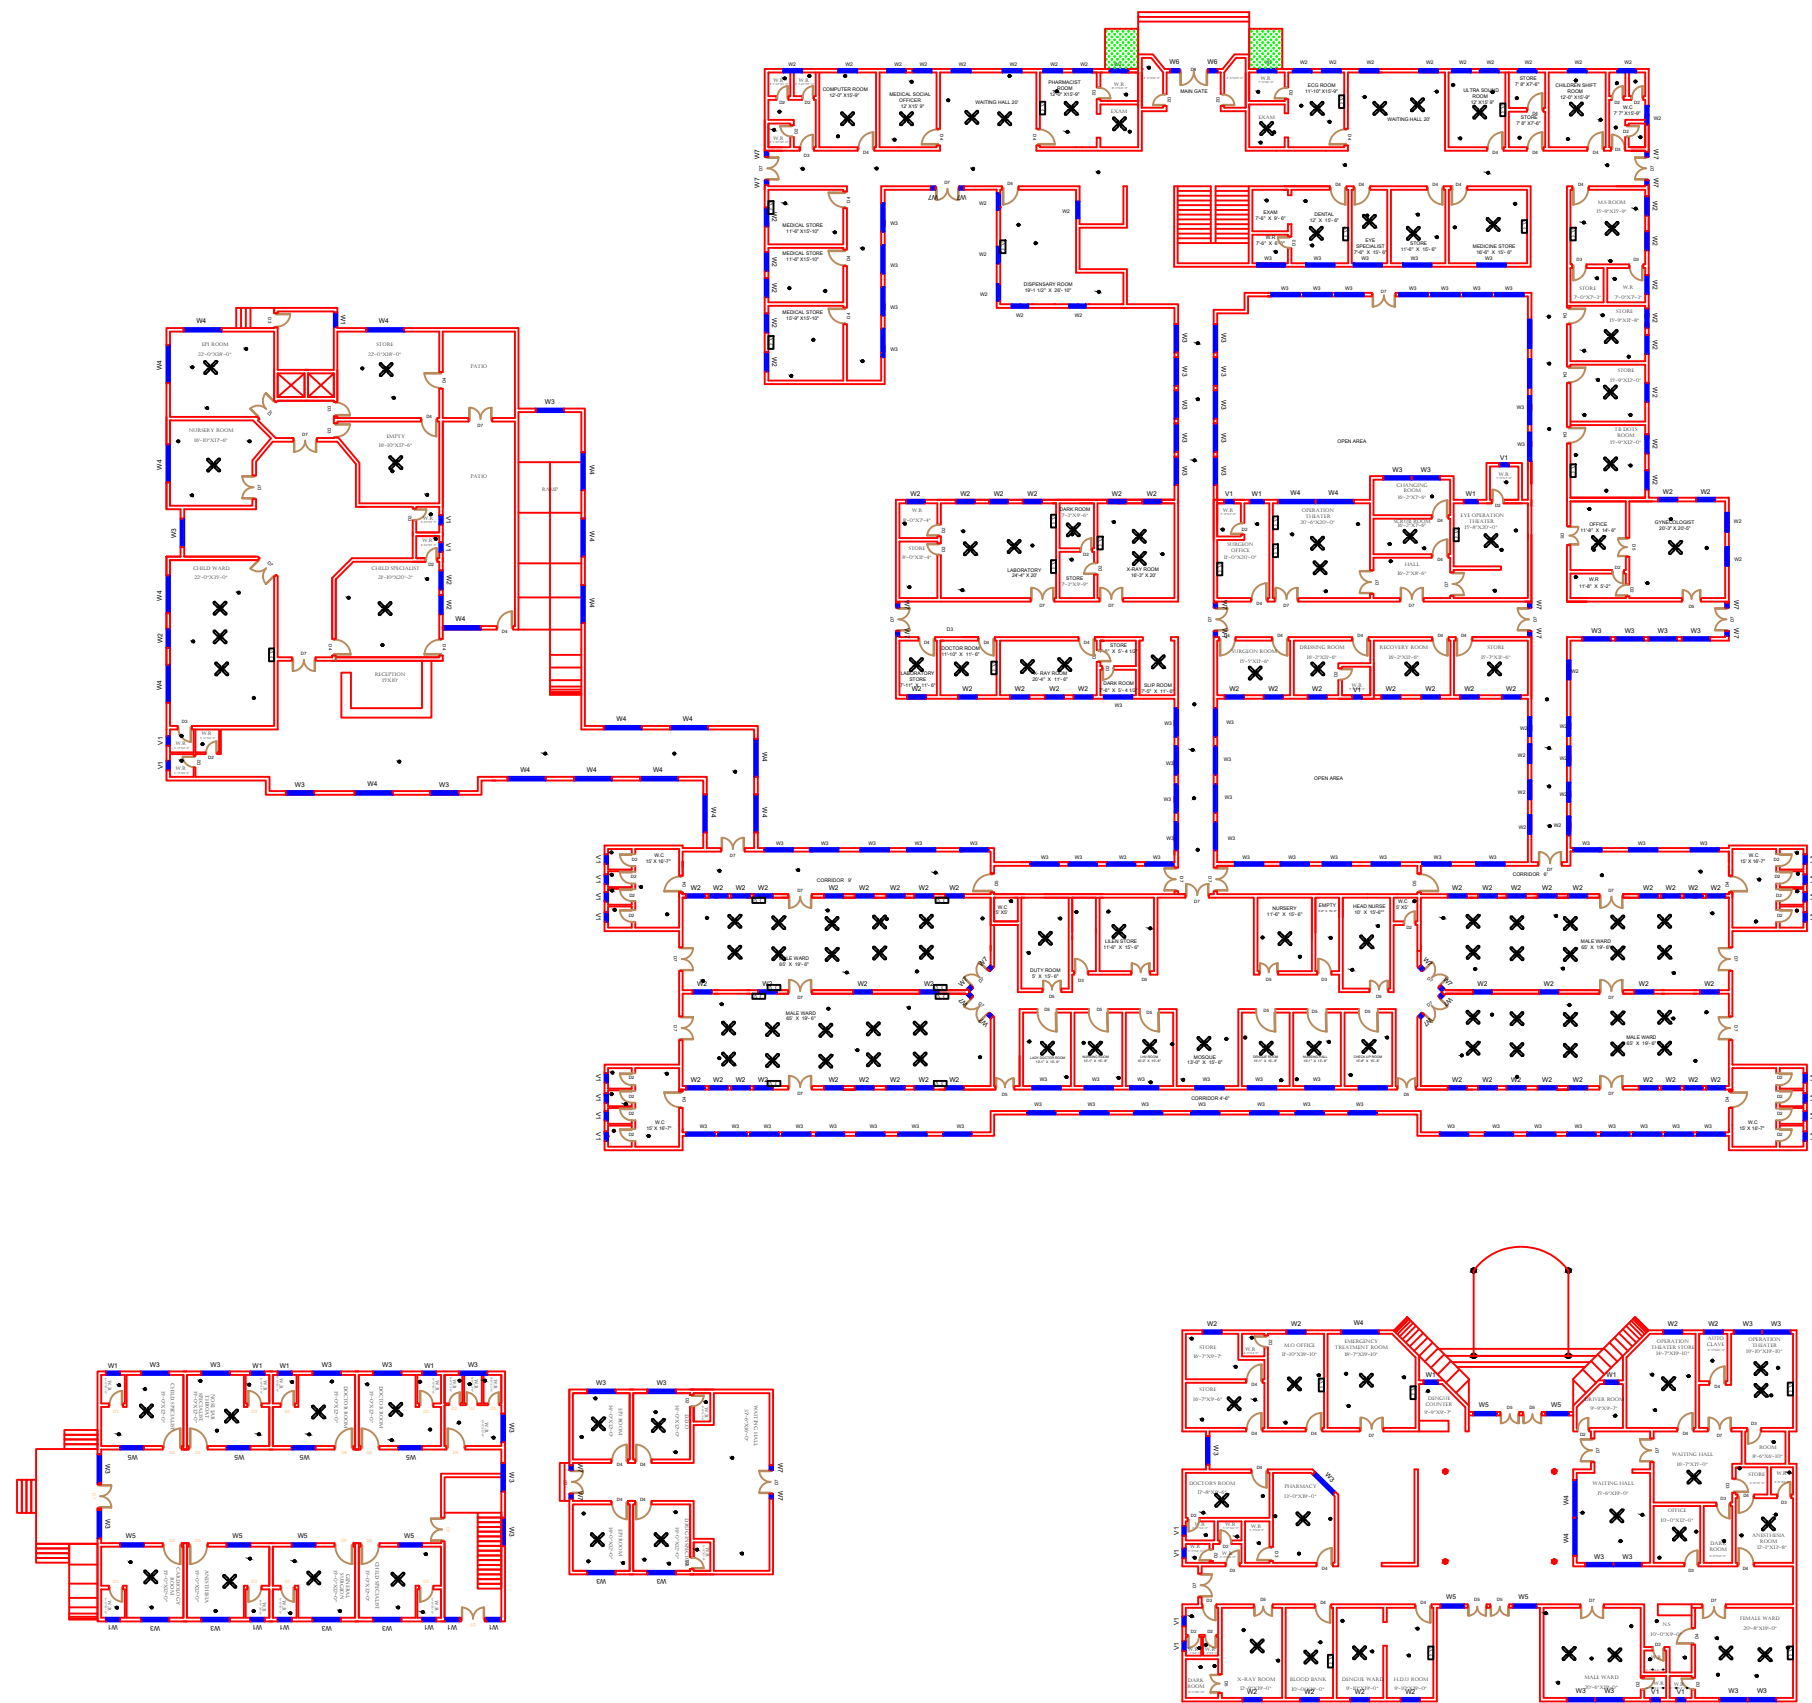

Legends:

Residential Area	
Road	
Wall	
Power Line	
OHT	
Tree	
Man Hole	
Tube Well	
Light Pole	
Lawns	
Earthen Areas	
Asphalts Roads	
Tough Pavers	
P.C.C / Plinth Protection	
Boundary Wall	
Brick Pavers / Soling	
Drain	
Tap	
Hand Pump	
Air Conditioner	
Tube Light	
Fan	
Roof Light	
Bulb	

AREA

AREA WITHIN BOUNDARY WALL	466530.23 Sft
AREA OF CLINICAL BLOCK	6999.9848 Sft
PLINTH AREA OF BLOCK	Sft

OPENING SCHEDULE OF DOORS AND WINDOWS

DOORS	WIDTH	HEIGHT	WINDOWS	WIDTH	HEIGHT
D1	2'-6"	7'-0"	W1	2'-6"	2'-6"
D2	3'-0"	7'-0"	W2	3'-0"	3'-0"
D3	3'-6"	7'-0"	W3	4'-0"	4'-0"
D4	4'-0"	7'-0"	W4	5'-0"	5'-0"
D5	5'-0"	7'-0"	W5	6'-0"	6'-0"
D6	6'-0"	7'-0"	W6	8'-0"	8'-0"
D7	7'-0"	7'-0"	W7	9'-0"	9'-0"
D8	8'-0"	7'-0"	V1		
D9			V2		

Project:
**CAD MAPPING OF TEHSIL
HEAD QUARTER HOSPITALS,
PUNJAB**



Client: GOVERNMENT OF THE PUNJAB PRIMARY & SECONDARY HEALTHCARE DEPARTMENT	Consultant: SKAFS CONSULTANT (Pvt.) Limited ENGINEERING AND ENVIRONMENT CONSULTANT
---	--

Drawing Title:
**THQ JAMPUR
ELECTRICAL PLAN (GROUND FLOOR)**

Drawing No.
SKAFS/JAMPUR /15

ELECTRICAL LAYOUT PLAN OF THQ HOSPITAL JAMPUR

FIRST FLOOR

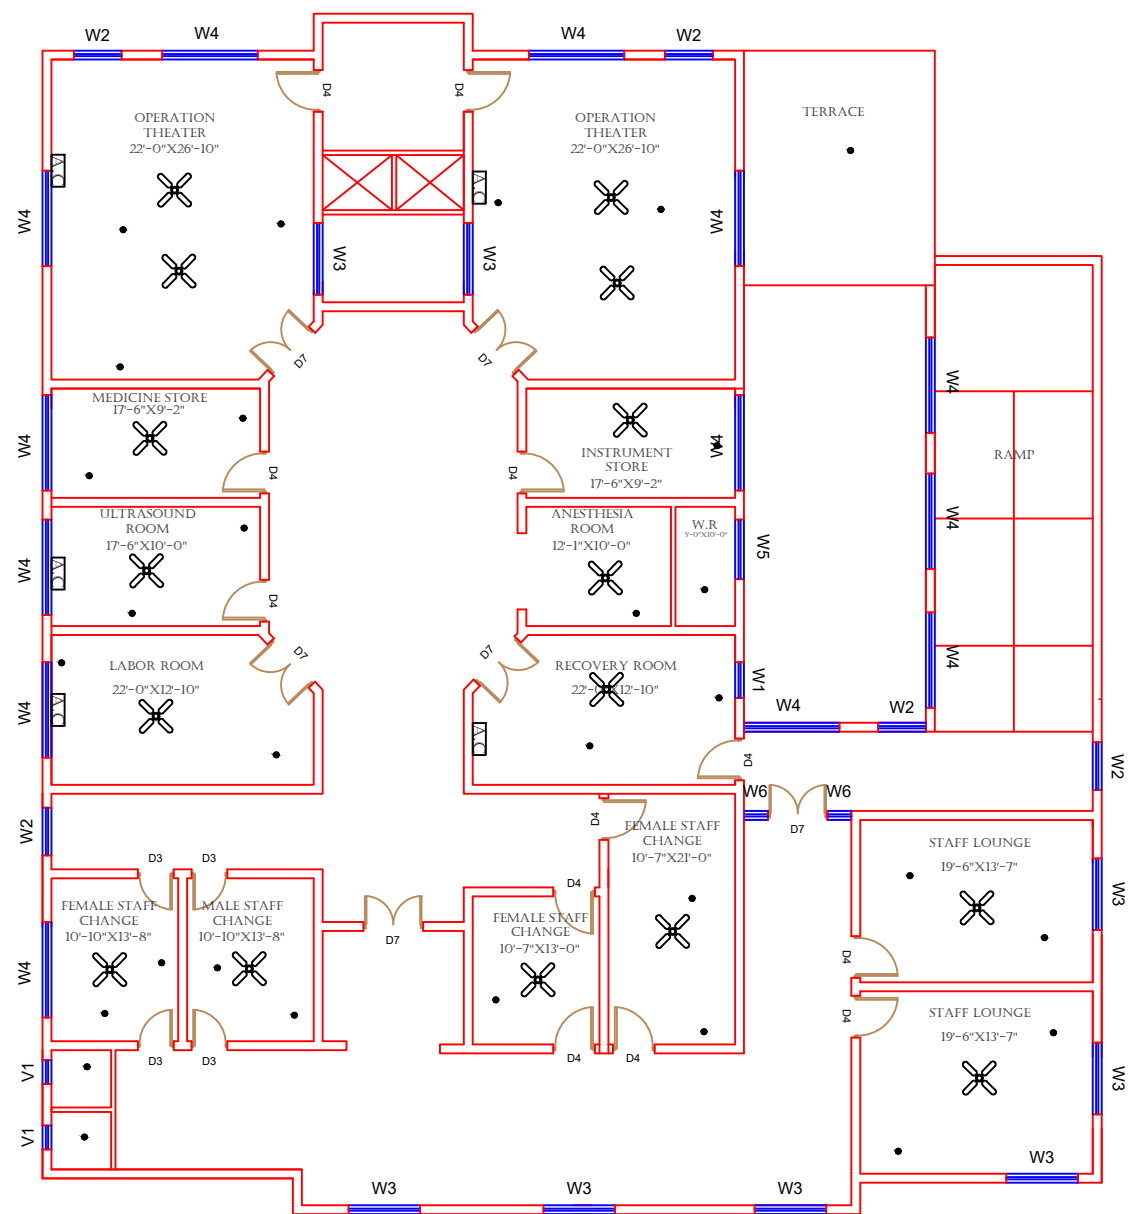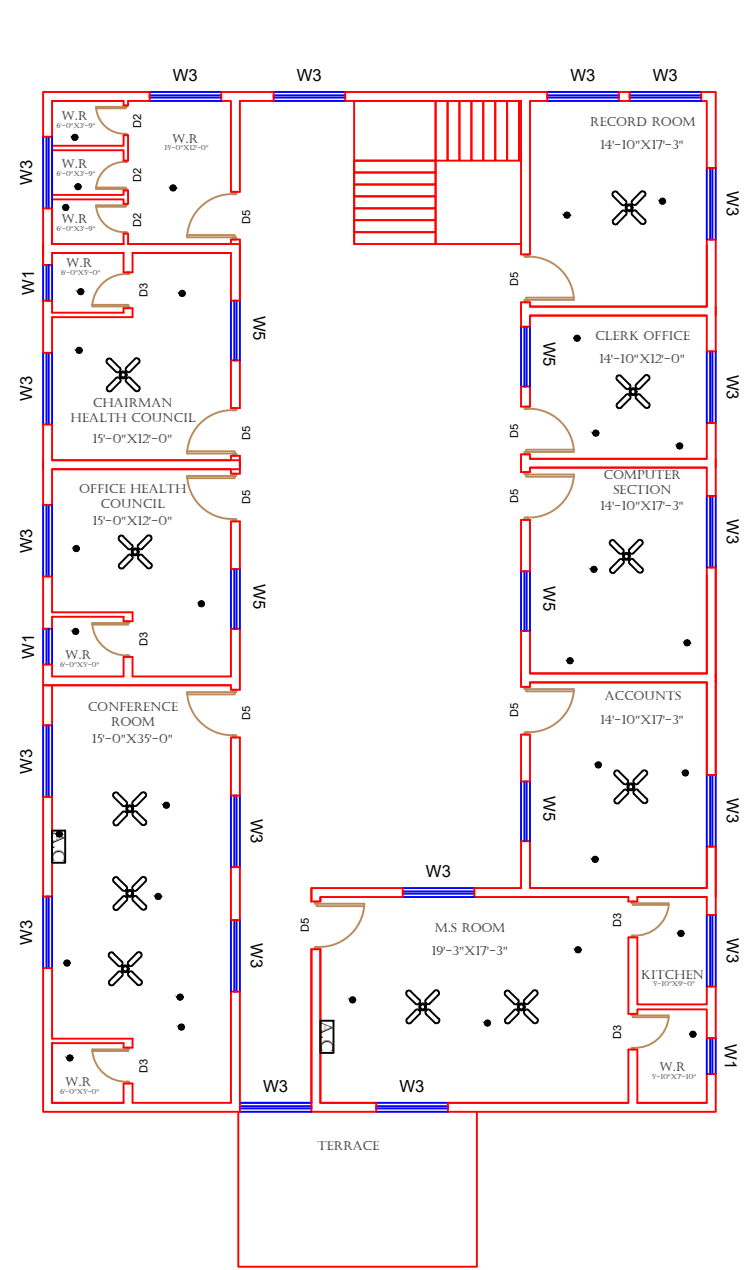

FIRST FLOOR

Legends:

Residential Area	
Road	
Wall	
Power Line	
OHT	
Tree	
Man Hole	
Tube Well	
Light Pole	
Lawns	
Earthen Areas	
Asphalts Roads	
Tough Pavers	
P.C.C / Plinth Protection	
Boundary Wall	
Brick Pavers / Soling	
Drain	
Tap	
Hand Pump	
Air Conditioner	
Tube Light	
Fan	
Roof Light	
Bulb	

AREA	
AREA WITHIN BOUNDARY WALL	466530.23 Sft
AREA OF CLINICAL BLOCK	6999.9848 Sft
PLINTH AREA OF BLOCK	Sft

OPENING SCHEDULE OF DOORS AND WINDOWS					
DOORS	WIDTH	HEIGHT	WINDOWS	WIDTH	HEIGHT
D1	2'-6"	7'-0"	W1	2'-6"	2'-6"
D2	3'-0"	7'-0"	W2	3'-0"	3'-0"
D3	3'-6"	7'-0"	W3	4'-0"	4'-0"
D4	4'-0"	7'-0"	W4	5'-0"	5'-0"
D5	5'-0"	7'-0"	W5	6'-0"	6'-0"
D6	6'-0"	7'-0"	W6	8'-0"	8'-0"
D7	7'-0"	7'-0"	W7	9'-0"	9'-0"
D8	8'-0"	7'-0"	V1		
D9			V2		

Project: CAD MAPPING OF TEHSIL HEAD QUARTER HOSPITALS, PUNJAB

Client:	Consultant:
GOVERNMENT OF THE PUNJAB PRIMARY & SECONDARY HEALTHCARE DEPARTMENT	SKAFS CONSULTANT (Pvt.) Limited ENGINEERING AND ENVIRONMENT CONSULTANT

Drawing Title: THQ JAMPUR ELECTRICAL PLAN (FIRST FLOOR)

Drawing No. SKAFS/JAMPUR /16