

MASTER PLAN OF THQ HOSPITAL KALLAR KAHAR

PART 1

PART 2

PART 3

PART 4



Legends:

Residential Area	
Road	
Wall	
Power Line	
OHT	
Tree	
Man Hole	
Tube Well	
Light Pole	
Lawns	
Earthen Areas	
Asphalts Roads	
Tough Pavers	
P.C.C / Plinth Protection	
Boundary Wall	
Brick Pavers / Soling	
Drain	
Tap	
Hand Pump	
Air Conditioner	
Tube Light	
Fan	
Roof Light	
Bulb	

AREA	
AREA WITHIN BOUNDARY WALL	99362.626 Sft
AREA OF CLINICAL BLOCK	24824.87 Sft
PLINTH AREA OF BLOCK	12412.435 Sft

OPENING SCHEDULE OF DOORS AND WINDOWS					
DOORS	WIDTH	HEIGHT	WINDOWS	WIDTH	HEIGHT
D1	3'-6"	8'-3"	W1	4'-0"	5'-0"
D2	2'-6"	7'-0"	W2	5'-0"	3'-6"
D3	3'-0"	8'-3"	W3	6'-0"	5'-6"
D4	4'-10"	8'-3"	W4	3'-0"	8'-3"
D5	3'-0"	7'-0"	W5	6'-0"	7'-6"

Project: CAD MAPPING OF TEHSIL HEAD QUARTER HOSPITALS, PUNJAB



Client: GOVERNMENT OF THE PUNJAB PRIMARY & SECONDARY HEALTHCARE DEPARTMENT	Consultant: SKAFS CONSULTANT (Pvt.) Limited ENGINEERING AND ENVIRONMENT CONSULTANT
---	--

Drawing Title:
THQ KALLAR KAHAR
HOSPITAL MASTER PLAN

Drawing No.
SKAFS/K-KAHAR /03

MASTER PLAN OF THQ HOSPITAL KALLAR KAHAR

PART 1

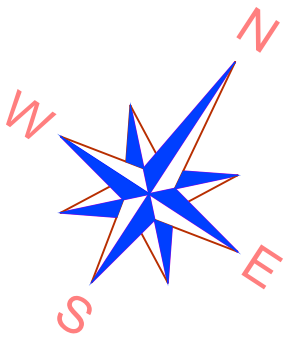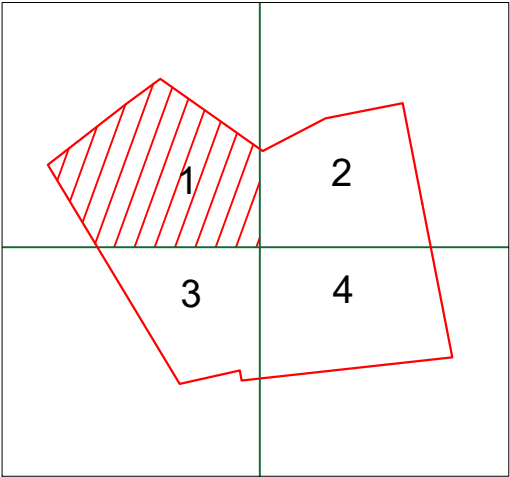

Legends:

Residential Area	
Road	
Wall	
Power Line	
OHT	
Tree	
Man Hole	
Tube Well	
Light Pole	
Lawns	
Earthen Areas	
Asphalts Roads	
Tough Pavers	
P.C.C / Plinth Protection	
Boundary Wall	
Brick Pavers / Soling	
Drain	
Tap	
Hand Pump	
Air Conditioner	
Tube Light	
Fan	
Roof Light	
Bulb	

AREA	
AREA WITHIN BOUNDARY WALL	99362.626 Sft
AREA OF CLINICAL BLOCK	24824.87 Sft
PLINTH AREA OF BLOCK	12412.435Sft

OPENING SCHEDULE OF DOORS AND WINDOWS					
DOORS	WIDTH	HEIGHT	WINDOWS	WIDTH	HEIGHT
D1	3'-6"	8'-3"	W1	4'-0"	5'-0"
D2	2'-6"	7'-0"	W2	5'-0"	3'-6"
D3	3'-0"	8'-3"	W3	6'-0"	5'-6"
D4	4'-10"	8'-3"	W4	3'-0"	8'-3"
D5	3'-0"	7'-0"	W5	6'-0"	7'-6"

Project: **CAD MAPPING OF TEHSIL HEAD QUARTER HOSPITALS, PUNJAB**


Client: GOVERNMENT OF THE PUNJAB PRIMARY & SECONDARY HEALTHCARE DEPARTMENT	Consultant: SKAFS CONSULTANT (Pvt.) Limited ENGINEERING AND ENVIRONMENT CONSULTANT
---	--

Drawing Title: **THQ KALLAR KAHAR HOSPITAL MASTER PLAN PART 1**

Drawing No. **SKAFS/K-KAHAR /04**

MASTER PLAN OF THQ HOSPITAL KALLAR KAHAR

PART 2

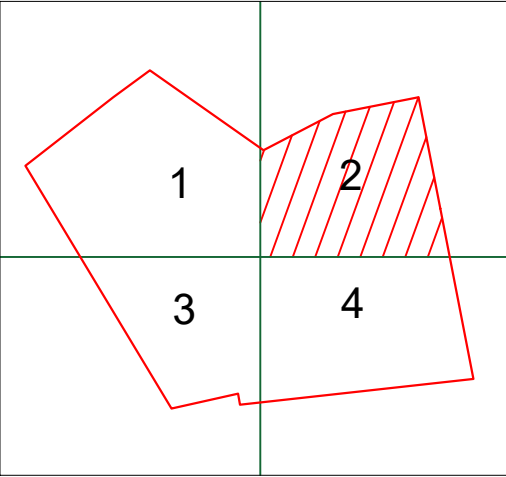

Legends:

Residential Area	
Road	
Wall	
Power Line	
OHT	
Tree	
Man Hole	
Tube Well	
Light Pole	
Lawns	
Earthen Areas	
Asphalts Roads	
Tough Pavers	
P.C.C / Plinth Protection	
Boundary Wall	
Brick Pavers / Soling	
Drain	
Tap	
Hand Pump	
Air Conditioner	
Tube Light	
Fan	
Roof Light	
Bulb	

AREA	
AREA WITHIN BOUNDARY WALL	99362.626 Sft
AREA OF CLINICAL BLOCK	24824.87 Sft
PLINTH AREA OF BLOCK	12412.435 Sft

OPENING SCHEDULE OF DOORS AND WINDOWS					
DOORS	WIDTH	HEIGHT	WINDOWS	WIDTH	HEIGHT
D1	3'-6"	8'-3"	W1	4'-0"	5'-0"
D2	2'-6"	7'-0"	W2	5'-0"	3'-6"
D3	3'-0"	8'-3"	W3	6'-0"	5'-6"
D4	4'-10"	8'-3"	W4	3'-0"	8'-3"
D5	3'-0"	7'-0"	W5	6'-0"	7'-6"

Project: **CAD MAPPING OF TEHSIL HEAD QUARTER HOSPITALS, PUNJAB**


Client:	Consultant:
 GOVERNMENT OF THE PUNJAB PRIMARY & SECONDARY HEALTHCARE DEPARTMENT	 SKAFS CONSULTANT (Pvt.) Limited ENGINEERING AND ENVIRONMENT CONSULTANT

Drawing Title: **THQ KALLAR KAHAR HOSPITAL MASTER PLAN PART 2**

Drawing No. **SKAFS/K-KAHAR /05**

MASTER PLAN OF THQ HOSPITAL KALLAR KAHAR

PART 3

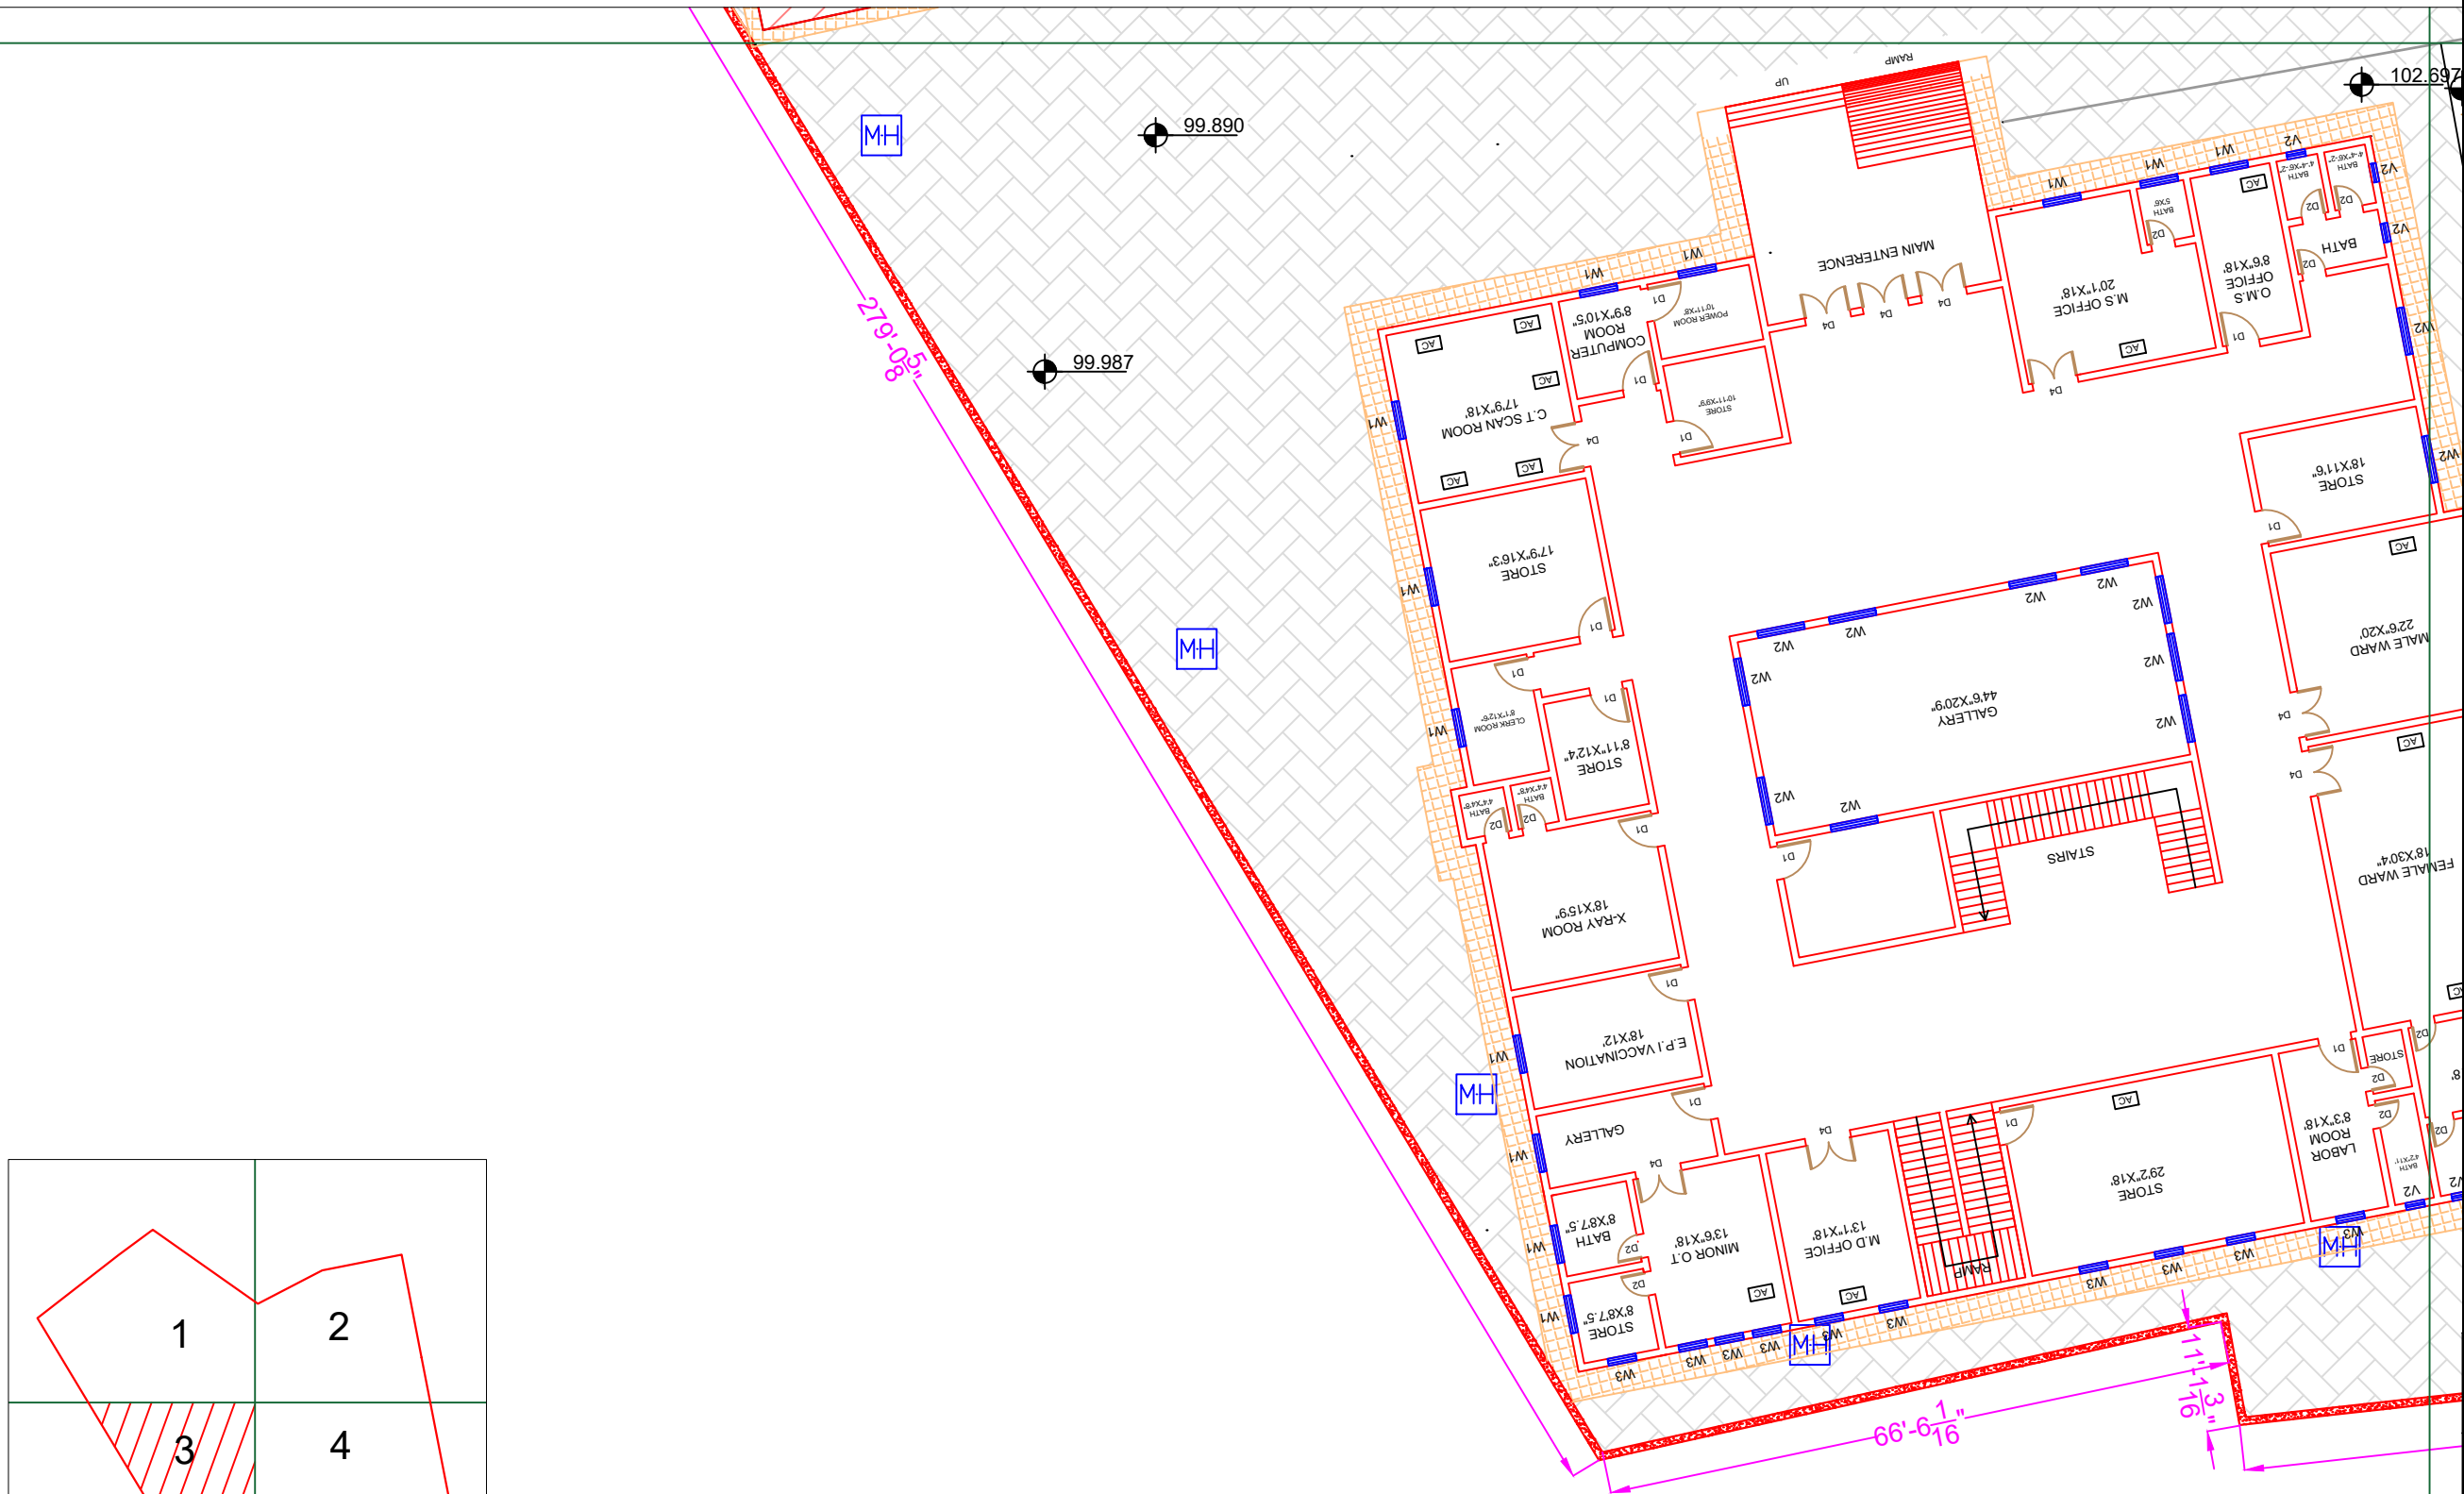

Legends:

Residential Area	
Road	
Wall	
Power Line	
OHT	
Tree	
Man Hole	
Tube Well	
Light Pole	
Lawns	
Earthen Areas	
Asphalts Roads	
Tough Pavers	
P.C.C / Plinth Protection	
Boundary Wall	
Brick Pavers / Soling	
Drain	
Tap	
Hand Pump	
Air Conditioner	
Tube Light	
Fan	
Roof Light	
Bulb	

AREA					
AREA WITHIN BOUNDARY WALL		99362.626 Sft			
AREA OF CLINICAL BLOCK		24824.87 Sft			
PLINTH AREA OF BLOCK		12412.435 Sft			

OPENING SCHEDULE OF DOORS AND WINDOWS					
DOORS	WIDTH	HEIGHT	WINDOWS	WIDTH	HEIGHT
D1	3'-6"	8'-3"	W1	4'-0"	5'-0"
D2	2'-6"	7'-0"	W2	5'-0"	3'-6"
D3	3'-0"	8'-3"	W3	6'-0"	5'-6"
D4	4'-10"	8'-3"	W4	3'-0"	8'-3"
D5	3'-0"	7'-0"	W5	6'-0"	7'-6"

Project: **CAD MAPPING OF TEHSIL HEAD QUARTER HOSPITALS, PUNJAB**

Client:

GOVERNMENT OF THE PUNJAB
PRIMARY & SECONDARY
HEALTHCARE DEPARTMENT

Consultant:


SKAFS CONSULTANT (Pvt.)
Limited
ENGINEERING AND ENVIRONMENT
CONSULTANT

Drawing Title: **THQ KALLAR KAHAR HOSPITAL MASTER PLAN PART 3**

Drawing No. **SKAFS/K-KAHAR /06**

MASTER PLAN OF THQ HOSPITAL KALLAR KAHAR

PART 4

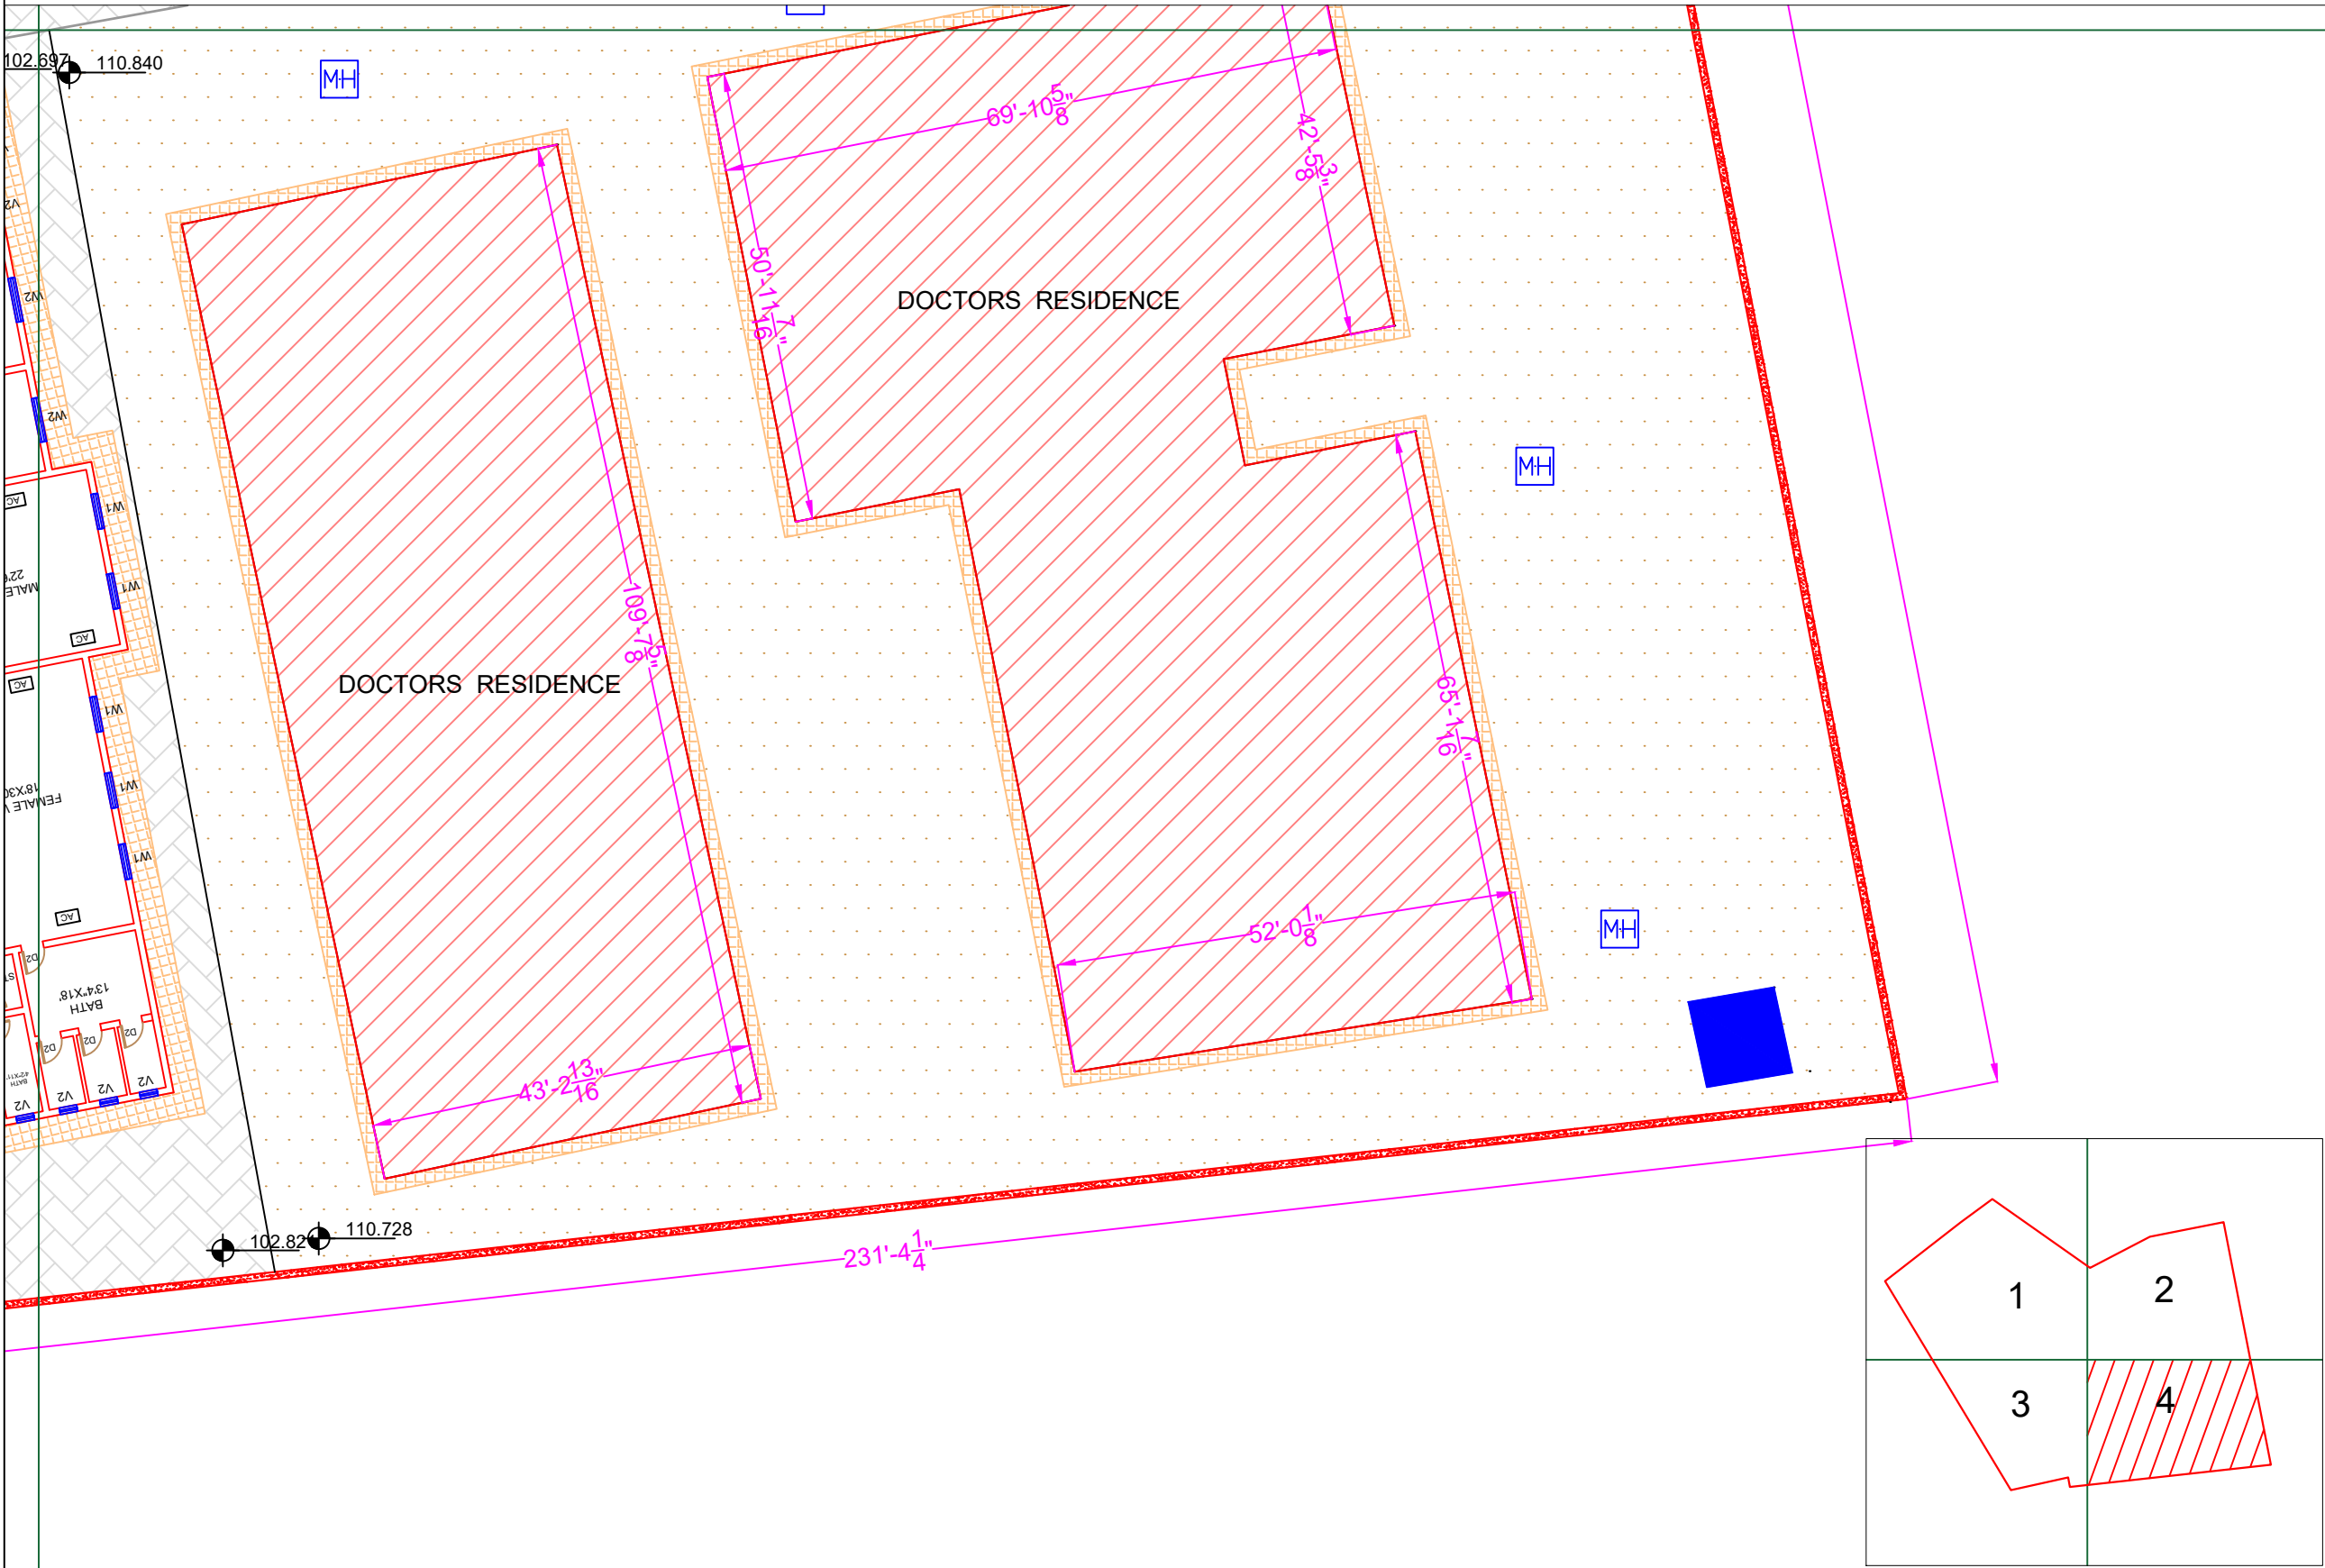

Legends:

Residential Area	
Road	
Wall	
Power Line	
OHT	
Tree	
Man Hole	
Tube Well	
Light Pole	
Lawns	
Earthen Areas	
Asphalts Roads	
Tough Pavers	
P.C.C / Plinth Protection	
Boundary Wall	
Brick Pavers / Soling	
Drain	
Tap	
Hand Pump	
Air Conditioner	
Tube Light	
Fan	
Roof Light	
Bulb	

AREA	
AREA WITHIN BOUNDARY WALL	99362.626 Sft
AREA OF CLINICAL BLOCK	24824.87 Sft
PLINTH AREA OF BLOCK	12412.435 Sft

OPENING SCHEDULE OF DOORS AND WINDOWS					
DOORS	WIDTH	HEIGHT	WINDOWS	WIDTH	HEIGHT
D1	3'-6"	8'-3"	W1	4'-0"	5'-0"
D2	2'-6"	7'-0"	W2	5'-0"	3'-6"
D3	3'-0"	8'-3"	W3	6'-0"	5'-6"
D4	4'-10"	8'-3"	W4	3'-0"	8'-3"
D5	3'-0"	7'-0"	W5	6'-0"	7'-6"

Project: CAD MAPPING OF TEHSIL HEAD QUARTER HOSPITALS, PUNJAB


Client:	Consultant:
GOVERNMENT OF THE PUNJAB PRIMARY & SECONDARY HEALTHCARE DEPARTMENT	SKAFS CONSULTANT (Pvt.) Limited ENGINEERING AND ENVIRONMENT CONSULTANT

Drawing Title: THQ KALLAR KAHAR HOSPITAL MASTER PLAN PART 4

Drawing No. SKAFS/K-KAHAR /07

CLINICAL BLOCK OF THQ HOSPITAL KALLAR KAHAR

GROUND FLOOR PART 1

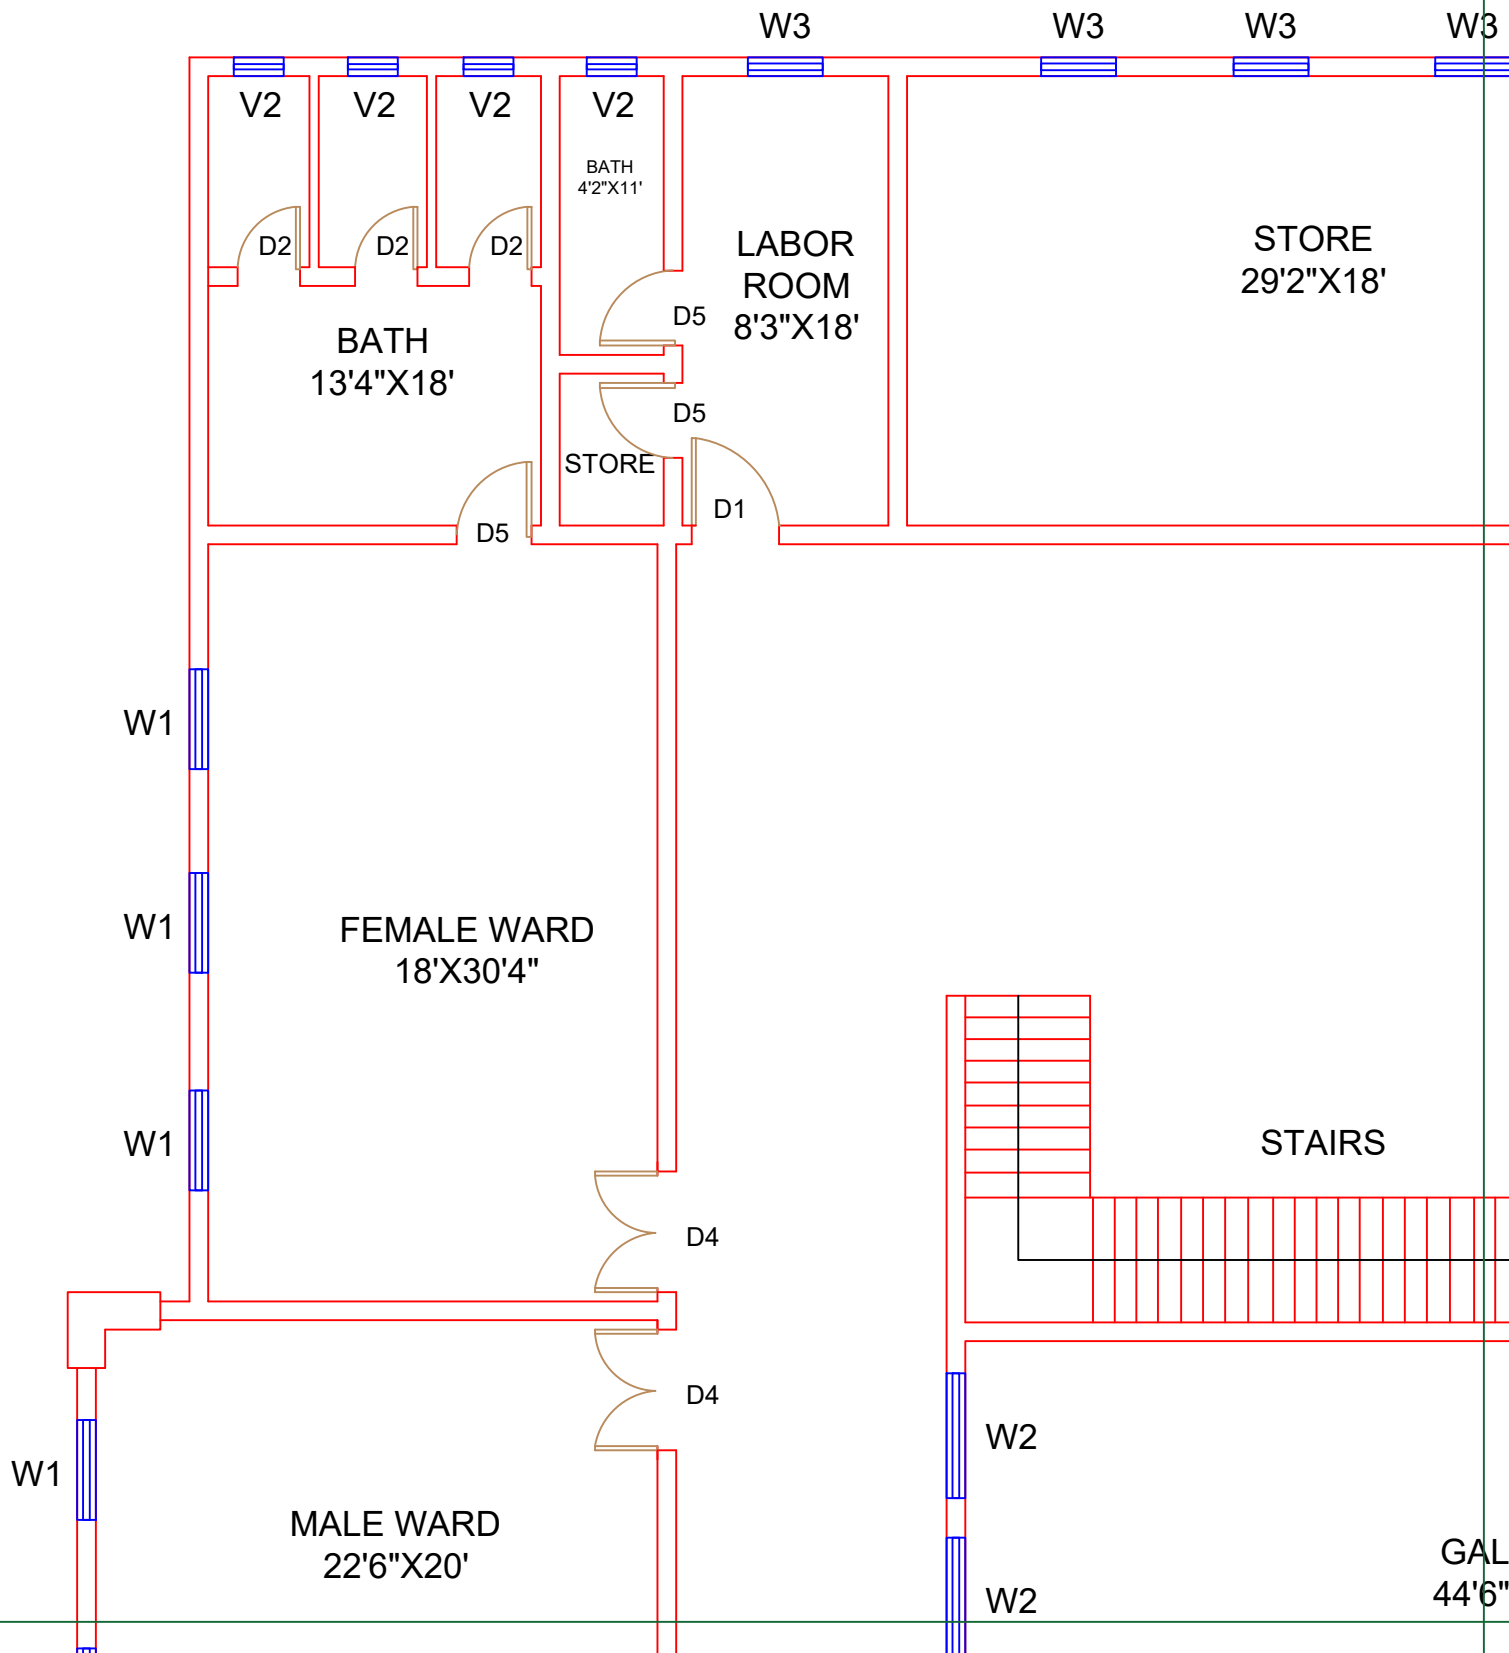

Legends:

Residential Area	
Road	
Wall	
Power Line	
OHT	
Tree	
Man Hole	
Tube Well	
Light Pole	
Lawns	
Earthen Areas	
Asphalts Roads	
Tough Pavers	
P.C.C / Plinth Protection	
Boundary Wall	
Brick Pavers / Soling	
Drain	
Tap	
Hand Pump	
Air Conditioner	
Tube Light	
Fan	
Roof Light	
Bulb	

AREA	
AREA WITHIN BOUNDARY WALL	99362.626 Sft
AREA OF CLINICAL BLOCK	24824.87 Sft
PLINTH AREA OF BLOCK	12412.435Sft

OPENING SCHEDULE OF DOORS AND WINDOWS					
DOORS	WIDTH	HEIGHT	WINDOWS	WIDTH	HEIGHT
D1	3'-6"	8'-3"	W1	4'-0"	5'-0"
D2	2'-6"	7'-0"	W2	5'-0"	3'-6"
D3	3'-0"	8'-3"	W3	6'-0"	5'-6"
D4	4'-10"	8'-3"	W4	3'-0"	8'-3"
D5	3'-0"	7'-0"	W5	6'-0"	7'-6"

Project: **CAD MAPPING OF TEHSIL HEAD QUARTER HOSPITALS, PUNJAB**

Client:

GOVERNMENT OF THE PUNJAB
PRIMARY & SECONDARY
HEALTHCARE DEPARTMENT

Consultant:


SKAFS CONSULTANT (Pvt.)
Limited
ENGINEERING AND ENVIRONMENT
CONSULTANT

Drawing Title: **THQ KALLAR KAHAR CLINICAL BLOCK PLAN (PART 1)**

Drawing No. **SKAFS/K-KAHAR /09**

CLINICAL BLOCK OF THQ HOSPITAL KALLAR KAHAR

GROUND FLOOR PART 2

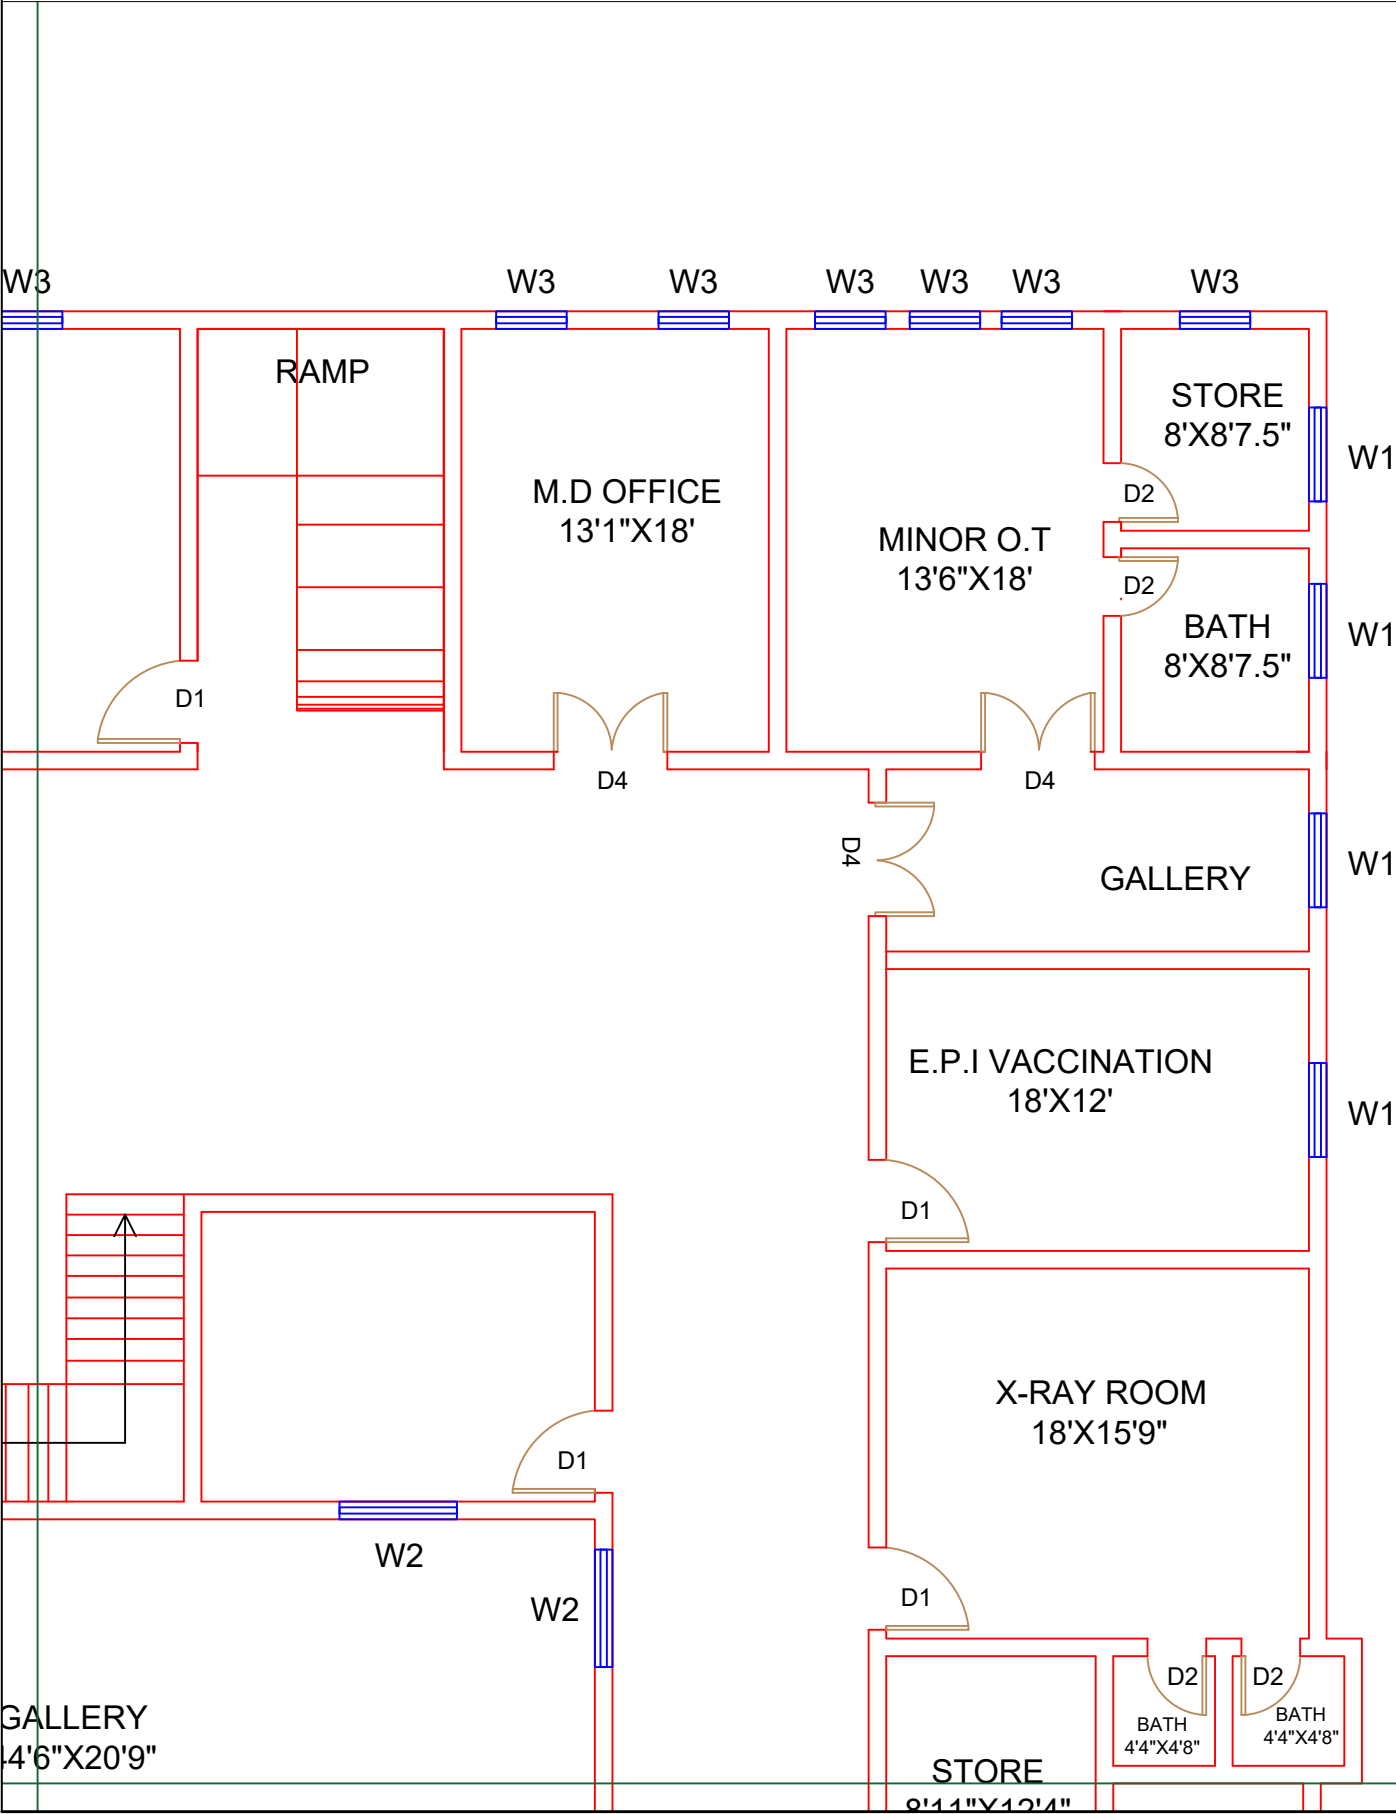

Legends:

Residential Area	
Road	
Wall	
Power Line	
OHT	
Tree	
Man Hole	
Tube Well	
Light Pole	
Lawns	
Earthen Areas	
Asphalts Roads	
Tough Pavers	
P.C.C / Plinth Protection	
Boundary Wall	
Brick Pavers / Soling	
Drain	
Tap	
Hand Pump	
Air Conditioner	
Tube Light	
Fan	
Roof Light	
Bulb	

AREA

AREA WITHIN BOUNDARY WALL	99362.626 Sft
AREA OF CLINICAL BLOCK	24824.87 Sft
PLINTH AREA OF BLOCK	12412.435Sft

OPENING SCHEDULE OF DOORS AND WINDOWS

DOORS	WIDTH	HEIGHT	WINDOWS	WIDTH	HEIGHT
D1	3'-6"	8'-3"	W1	4'-0"	5'-0"
D2	2'-6"	7'-0"	W2	5'-0"	3'-6"
D3	3'-0"	8'-3"	W3	6'-0"	5'-6"
D4	4'-10"	8'-3"	W4	3'-0"	8'-3"
D5	3'-0"	7'-0"	W5	6'-0"	7'-6"


Project: CAD MAPPING OF TEHSIL HEAD QUARTER HOSPITALS, PUNJAB

Client:	Consultant:
 GOVERNMENT OF THE PUNJAB PRIMARY & SECONDARY HEALTHCARE DEPARTMENT	 SKAFS CONSULTANT (Pvt.) Limited ENGINEERING AND ENVIRONMENT CONSULTANT

Drawing Title: THQ KALLAR KAHAR CLINICAL BLOCK PLAN (PART 2)

Drawing No. SKAFS/K-KAHAR /10

CLINICAL BLOCK OF THQ HOSPITAL KALLAR KAHAR
GROUND FLOOR PART 3

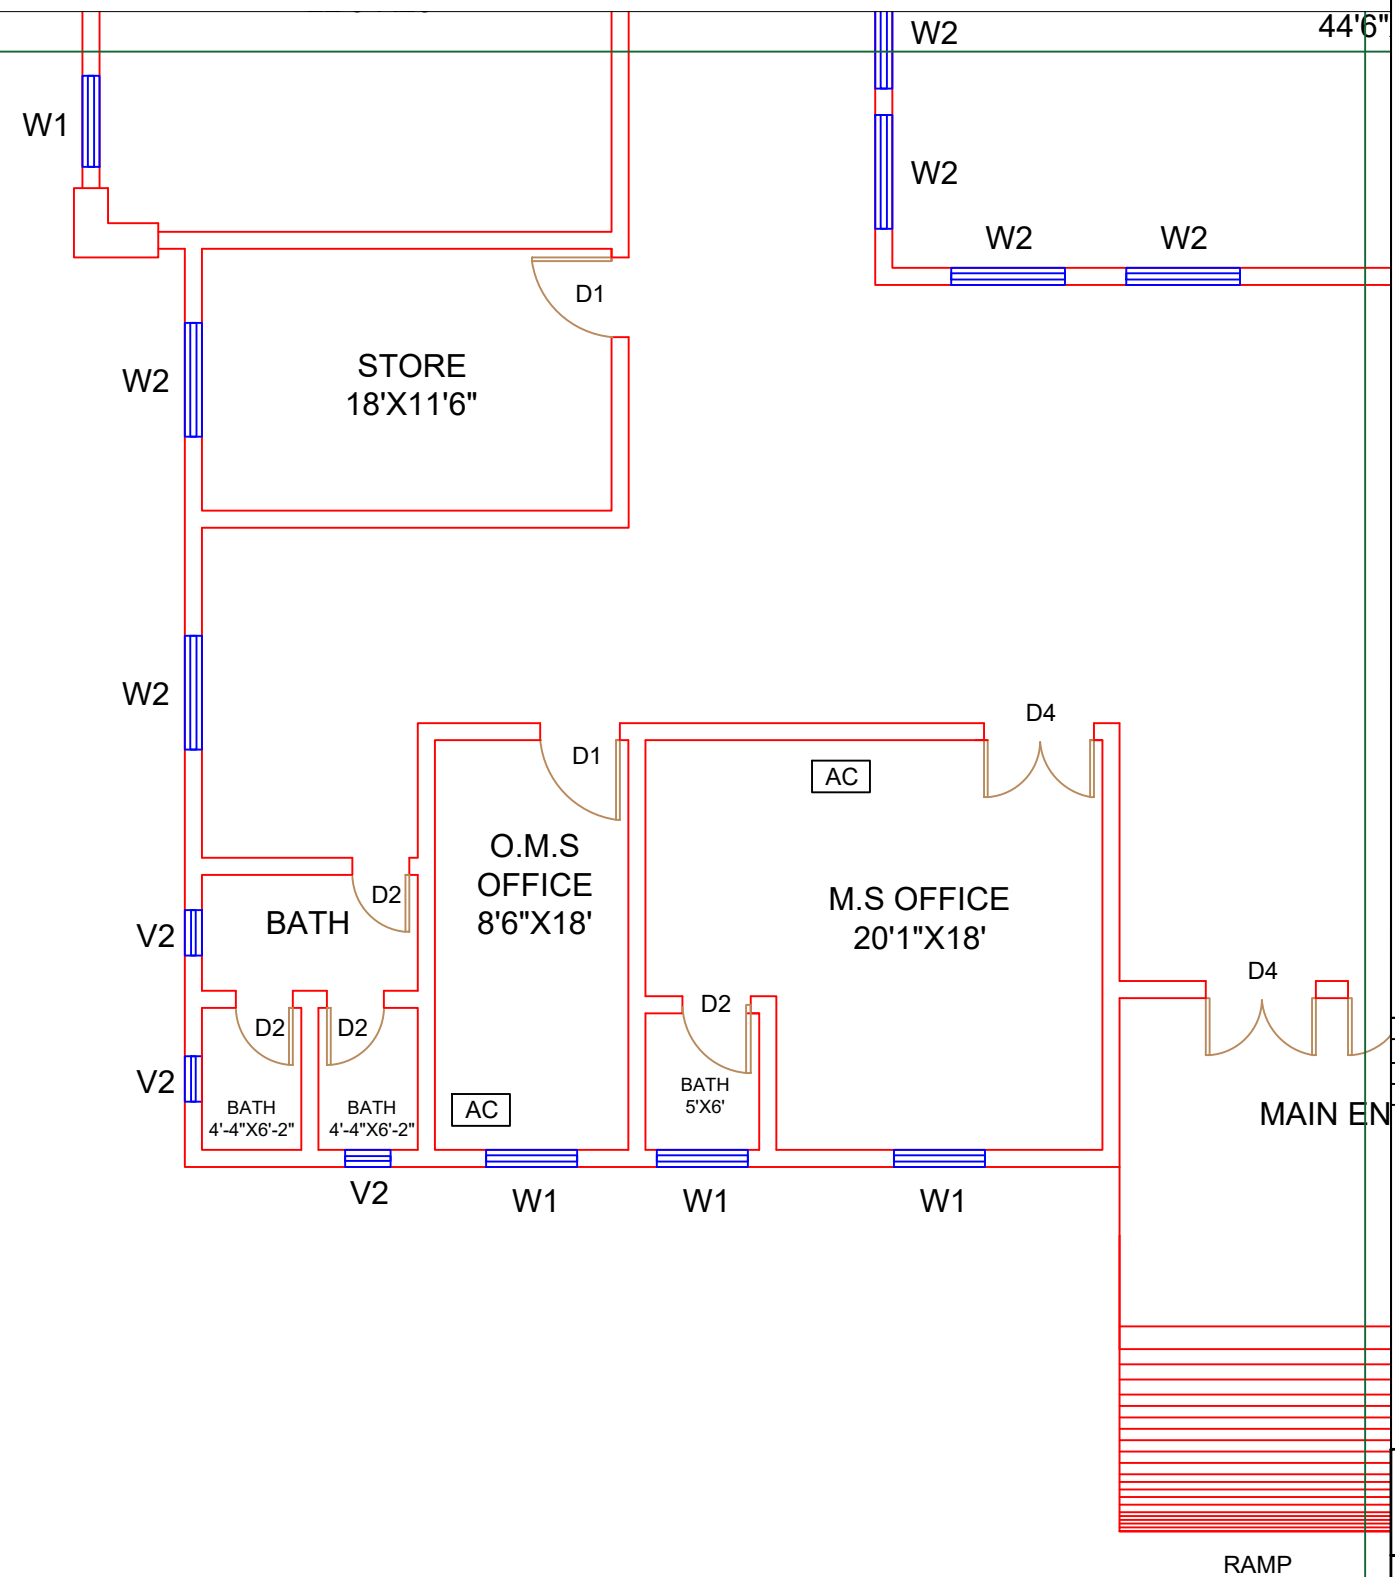

Legends:

Residential Area	
Road	
Wall	
Power Line	
OHT	
Tree	
Man Hole	
Tube Well	
Light Pole	
Lawns	
Earthen Areas	
Asphalts Roads	
Tough Pavers	
P.C.C / Plinth Protection	
Boundary Wall	
Brick Pavers / Soling	
Drain	
Tap	
Hand Pump	
Air Conditioner	
Tube Light	
Fan	
Roof Light	
Bulb	

AREA	
AREA WITHIN BOUNDARY WALL	99362.626 Sft
AREA OF CLINICAL BLOCK	24824.87 Sft
PLINTH AREA OF BLOCK	12412.435Sft

DOORS	WIDTH	HEIGHT	WINDOWS	WIDTH	HEIGHT
D1	3'-6"	8'-3"	W1	4'-0"	5'-0"
D2	2'-6"	7'-0"	W2	5'-0"	3'-6"
D3	3'-0"	8'-3"	W3	6'-0"	5'-6"
D4	4'-10" "	8'-3"	W4	3'-0"	8'-3"
D5	3'-0"	7'-0"	W5	6'-0"	7'-6"

Project: **CAD MAPPING OF TEHSIL
HEAD QUARTER HOSPITALS,
PUNJAB**


Client:  GOVERNMENT OF THE PUNJAB PRIMARY & SECONDARY HEALTHCARE DEPARTMENT	Consultant:  SKAFS CONSULTANT (Pvt.) Limited <i>ENGINEERING AND ENVIRONMENTAL CONSULTANT</i>
--	---

Drawing Title:
**THQ KALLAR KAHAR
CLINICAL BLOCK PLAN (PART 2)**

Drawing No. SKAFS/K-KAHAR /11

CLINICAL BLOCK OF THQ HOSPITAL KALLAR KAHAR

GROUND FLOOR PART 4

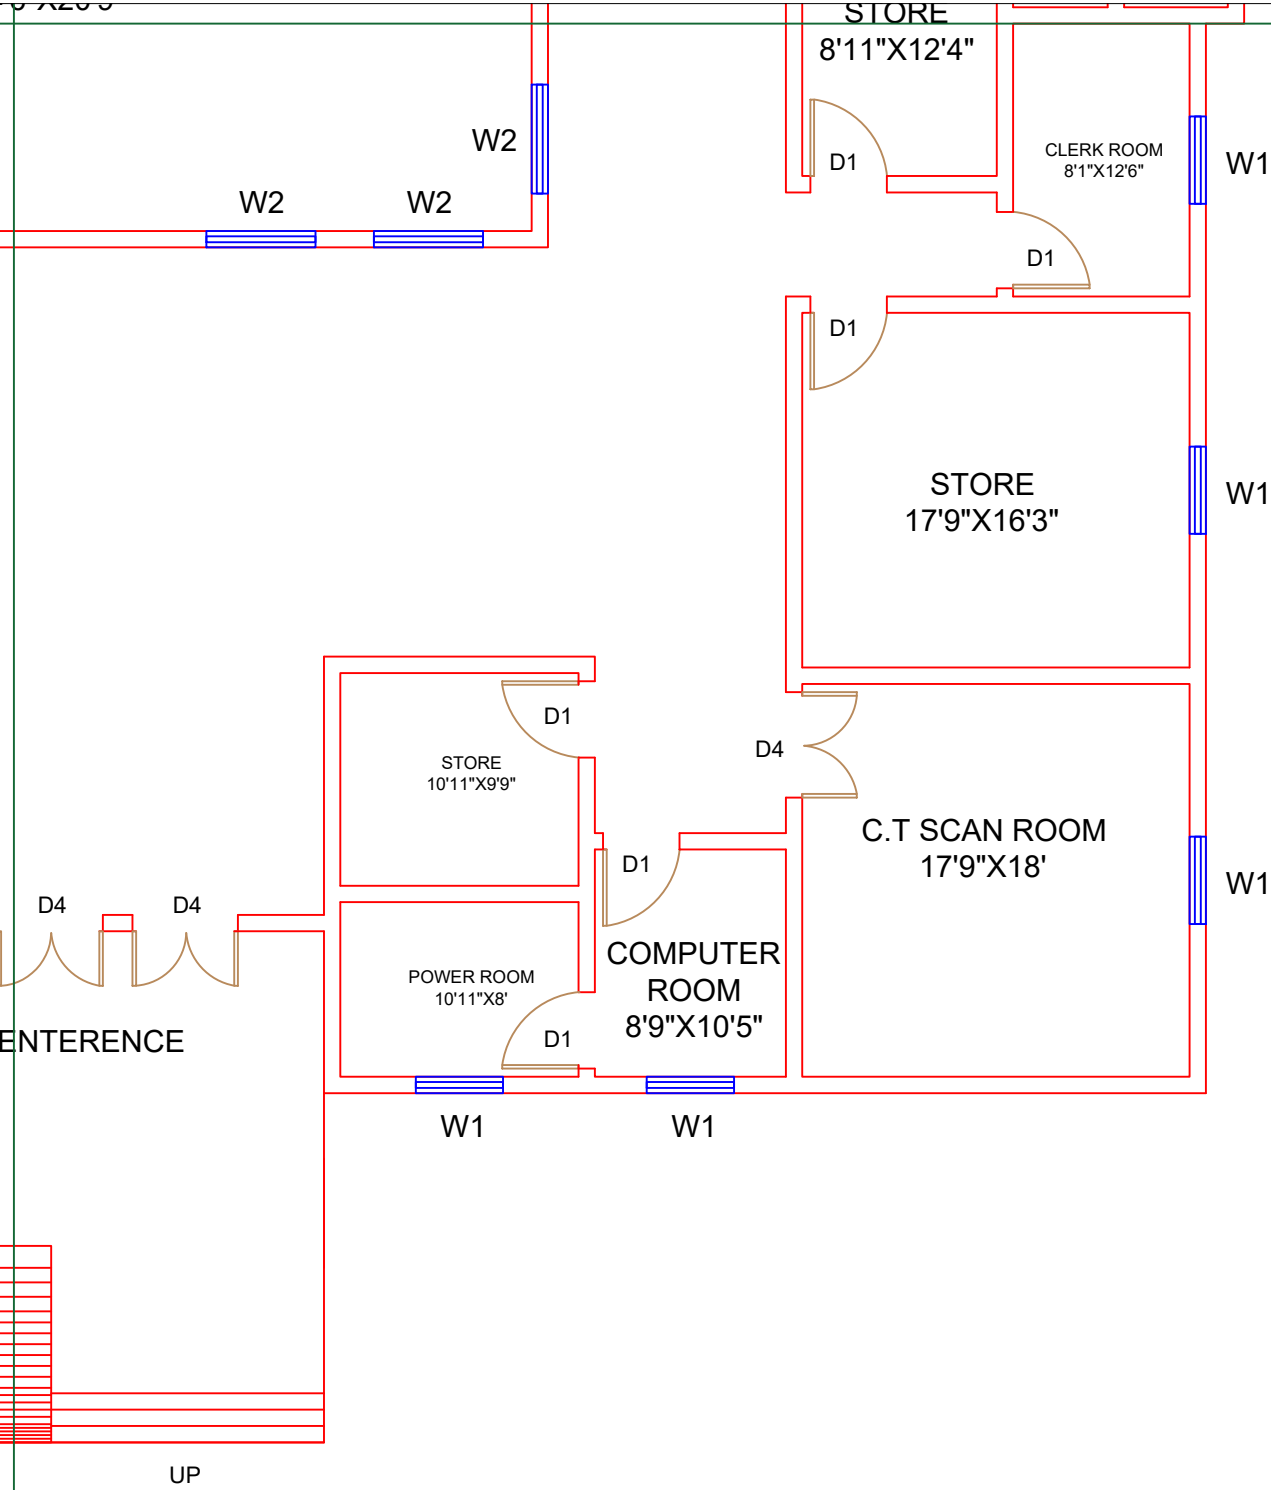

Legends:

Residential Area	
Road	
Wall	
Power Line	
OHT	
Tree	
Man Hole	
Tube Well	
Light Pole	
Lawns	
Earthen Areas	
Asphalts Roads	
Tough Pavers	
P.C.C / Plinth Protection	
Boundary Wall	
Brick Pavers / Soling	
Drain	
Tap	
Hand Pump	
Air Conditioner	
Tube Light	
Fan	
Roof Light	
Bulb	

AREA					
AREA WITHIN BOUNDARY WALL		99362.626 Sft			
AREA OF CLINICAL BLOCK		24824.87 Sft			
PLINTH AREA OF BLOCK		12412.435Sft			

OPENING SCHEDULE OF DOORS AND WINDOWS					
DOORS	WIDTH	HEIGHT	WINDOWS	WIDTH	HEIGHT
D1	3'-6"	8'-3"	W1	4'-0"	5'-0"
D2	2'-6"	7'-0"	W2	5'-0"	3'-6"
D3	3'-0"	8'-3"	W3	6'-0"	5'-6"
D4	4'-10"	8'-3"	W4	3'-0"	8'-3"
D5	3'-0"	7'-0"	W5	6'-0"	7'-6"

Project: CAD MAPPING OF TEHSIL HEAD QUARTER HOSPITALS, PUNJAB


Client: GOVERNMENT OF THE PUNJAB PRIMARY & SECONDARY HEALTHCARE DEPARTMENT	Consultant: SKAFS CONSULTANT (Pvt.) Limited ENGINEERING AND ENVIRONMENT CONSULTANT
---	--

Drawing Title: THQ KALLAR KAHAR CLINICAL BLOCK PLAN (PART 4)

Drawing No. SKAFS/K-KAHAR /12

CLINICAL BLOCK OF THQ HOSPITAL KALLAR KAHAR

FIRST FLOOR PART 1

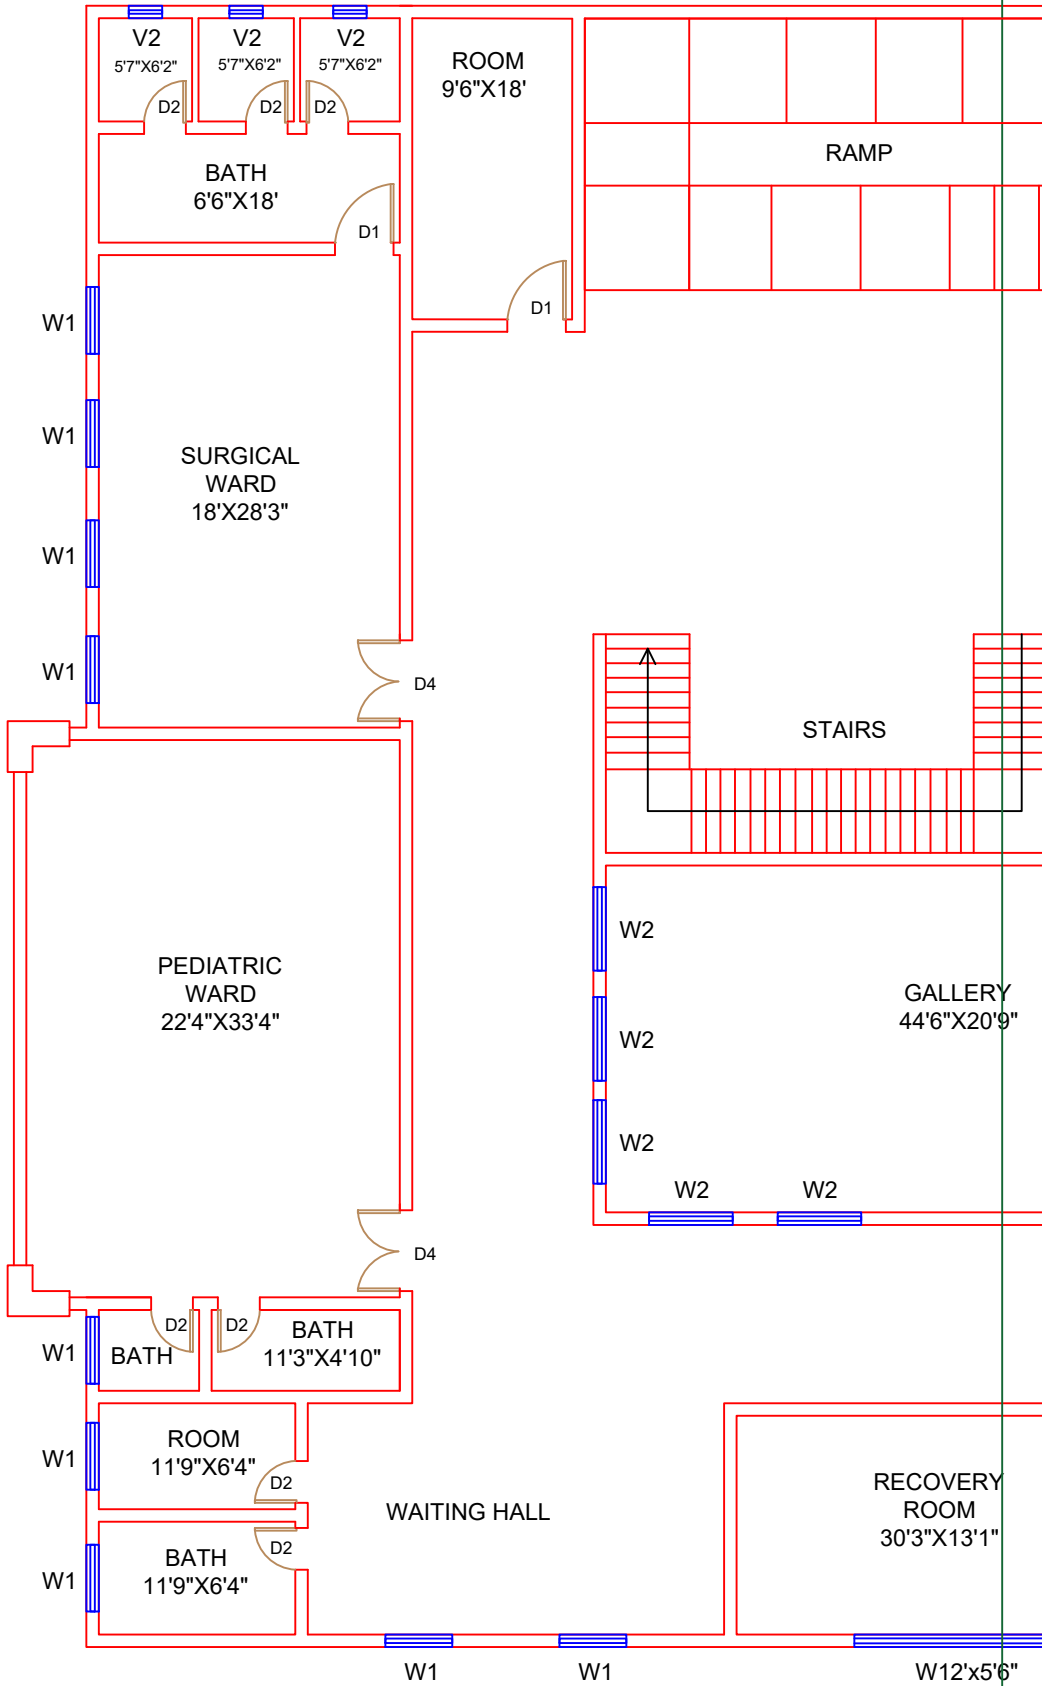

Legends:

Residential Area	
Road	
Wall	
Power Line	
OHT	
Tree	
Man Hole	
Tube Well	
Light Pole	
Lawns	
Earthen Areas	
Asphalts Roads	
Tough Pavers	
P.C.C / Plinth Protection	
Boundary Wall	
Brick Pavers / Soling	
Drain	
Tap	
Hand Pump	
Air Conditioner	
Tube Light	
Fan	
Roof Light	
Bulb	

AREA	
AREA WITHIN BOUNDARY WALL	99362.626 Sft
AREA OF CLINICAL BLOCK	24824.87 Sft
PLINTH AREA OF BLOCK	12412.435Sft

OPENING SCHEDULE OF DOORS AND WINDOWS					
DOORS	WIDTH	HEIGHT	WINDOWS	WIDTH	HEIGHT
D1	3'-6"	8'-3"	W1	4'-0"	5'-0"
D2	2'-6"	7'-0"	W2	5'-0"	3'-6"
D3	3'-0"	8'-3"	W3	6'-0"	5'-6"
D4	4'-10"	8'-3"	W4	3'-0"	8'-3"
D5	3'-0"	7'-0"	W5	6'-0"	7'-6"

Project: CAD MAPPING OF TEHSIL HEAD QUARTER HOSPITALS, PUNJAB


Client:	Consultant:
 GOVERNMENT OF THE PUNJAB PRIMARY & SECONDARY HEALTHCARE DEPARTMENT	 SKAFS CONSULTANT (Pvt.) Limited ENGINEERING AND ENVIRONMENT CONSULTANT

Drawing Title: THQ KALLAR KAHAR FIRST FLOOR PLAN (PART 1)

Drawing No. SKAFS/K-KAHAR /13

CLINICAL BLOCK OF THQ HOSPITAL KALLAR KAHAR

FIRST FLOOR PART 2

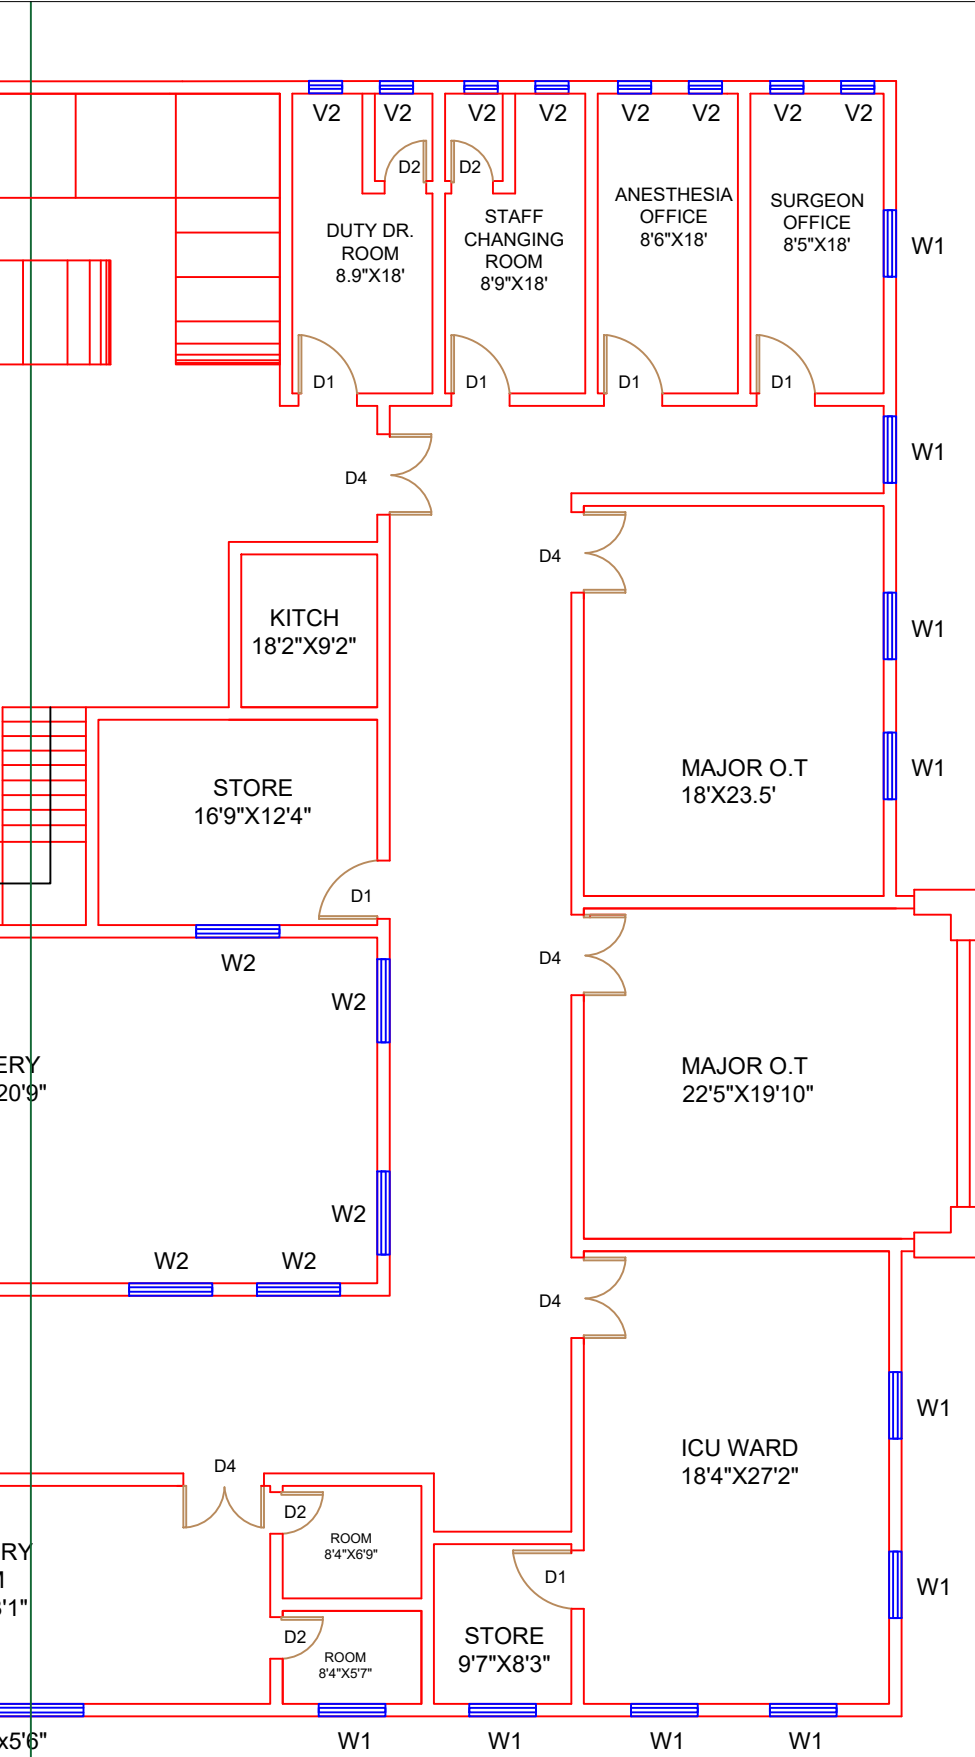

Legends:

Residential Area	
Road	
Wall	
Power Line	
OHT	
Tree	
Man Hole	
Tube Well	
Light Pole	
Lawns	
Earthen Areas	
Asphalts Roads	
Tough Pavers	
P.C.C / Plinth Protection	
Boundary Wall	
Brick Pavers / Soling	
Drain	
Tap	
Hand Pump	
Air Conditioner	
Tube Light	
Fan	
Roof Light	
Bulb	

AREA	
AREA WITHIN BOUNDARY WALL	99362.626 Sft
AREA OF CLINICAL BLOCK	24824.87 Sft
PLINTH AREA OF BLOCK	12412.435Sft

OPENING SCHEDULE OF DOORS AND WINDOWS					
DOORS	WIDTH	HEIGHT	WINDOWS	WIDTH	HEIGHT
D1	3'-6"	8'-3"	W1	4'-0"	5'-0"
D2	2'-6"	7'-0"	W2	5'-0"	3'-6"
D3	3'-0"	8'-3"	W3	6'-0"	5'-6"
D4	4'-10"	8'-3"	W4	3'-0"	8'-3"
D5	3'-0"	7'-0"	W5	6'-0"	7'-6"

Project: **CAD MAPPING OF TEHSIL HEAD QUARTER HOSPITALS, PUNJAB**


Client: GOVERNMENT OF THE PUNJAB PRIMARY & SECONDARY HEALTHCARE DEPARTMENT	Consultant: SKAFS CONSULTANT (Pvt.) Limited ENGINEERING AND ENVIRONMENT CONSULTANT
---	--

Drawing Title:
**THQ KALLAR KAHAR
FIRST FLOOR PLAN (PART 2)**

Drawing No. **SKAFS/K-KAHAR /14**

ELECTRICAL LAYOUT PLAN OF THQ HOSPITAL KALLAR KAHAR

GROUND FLOOR

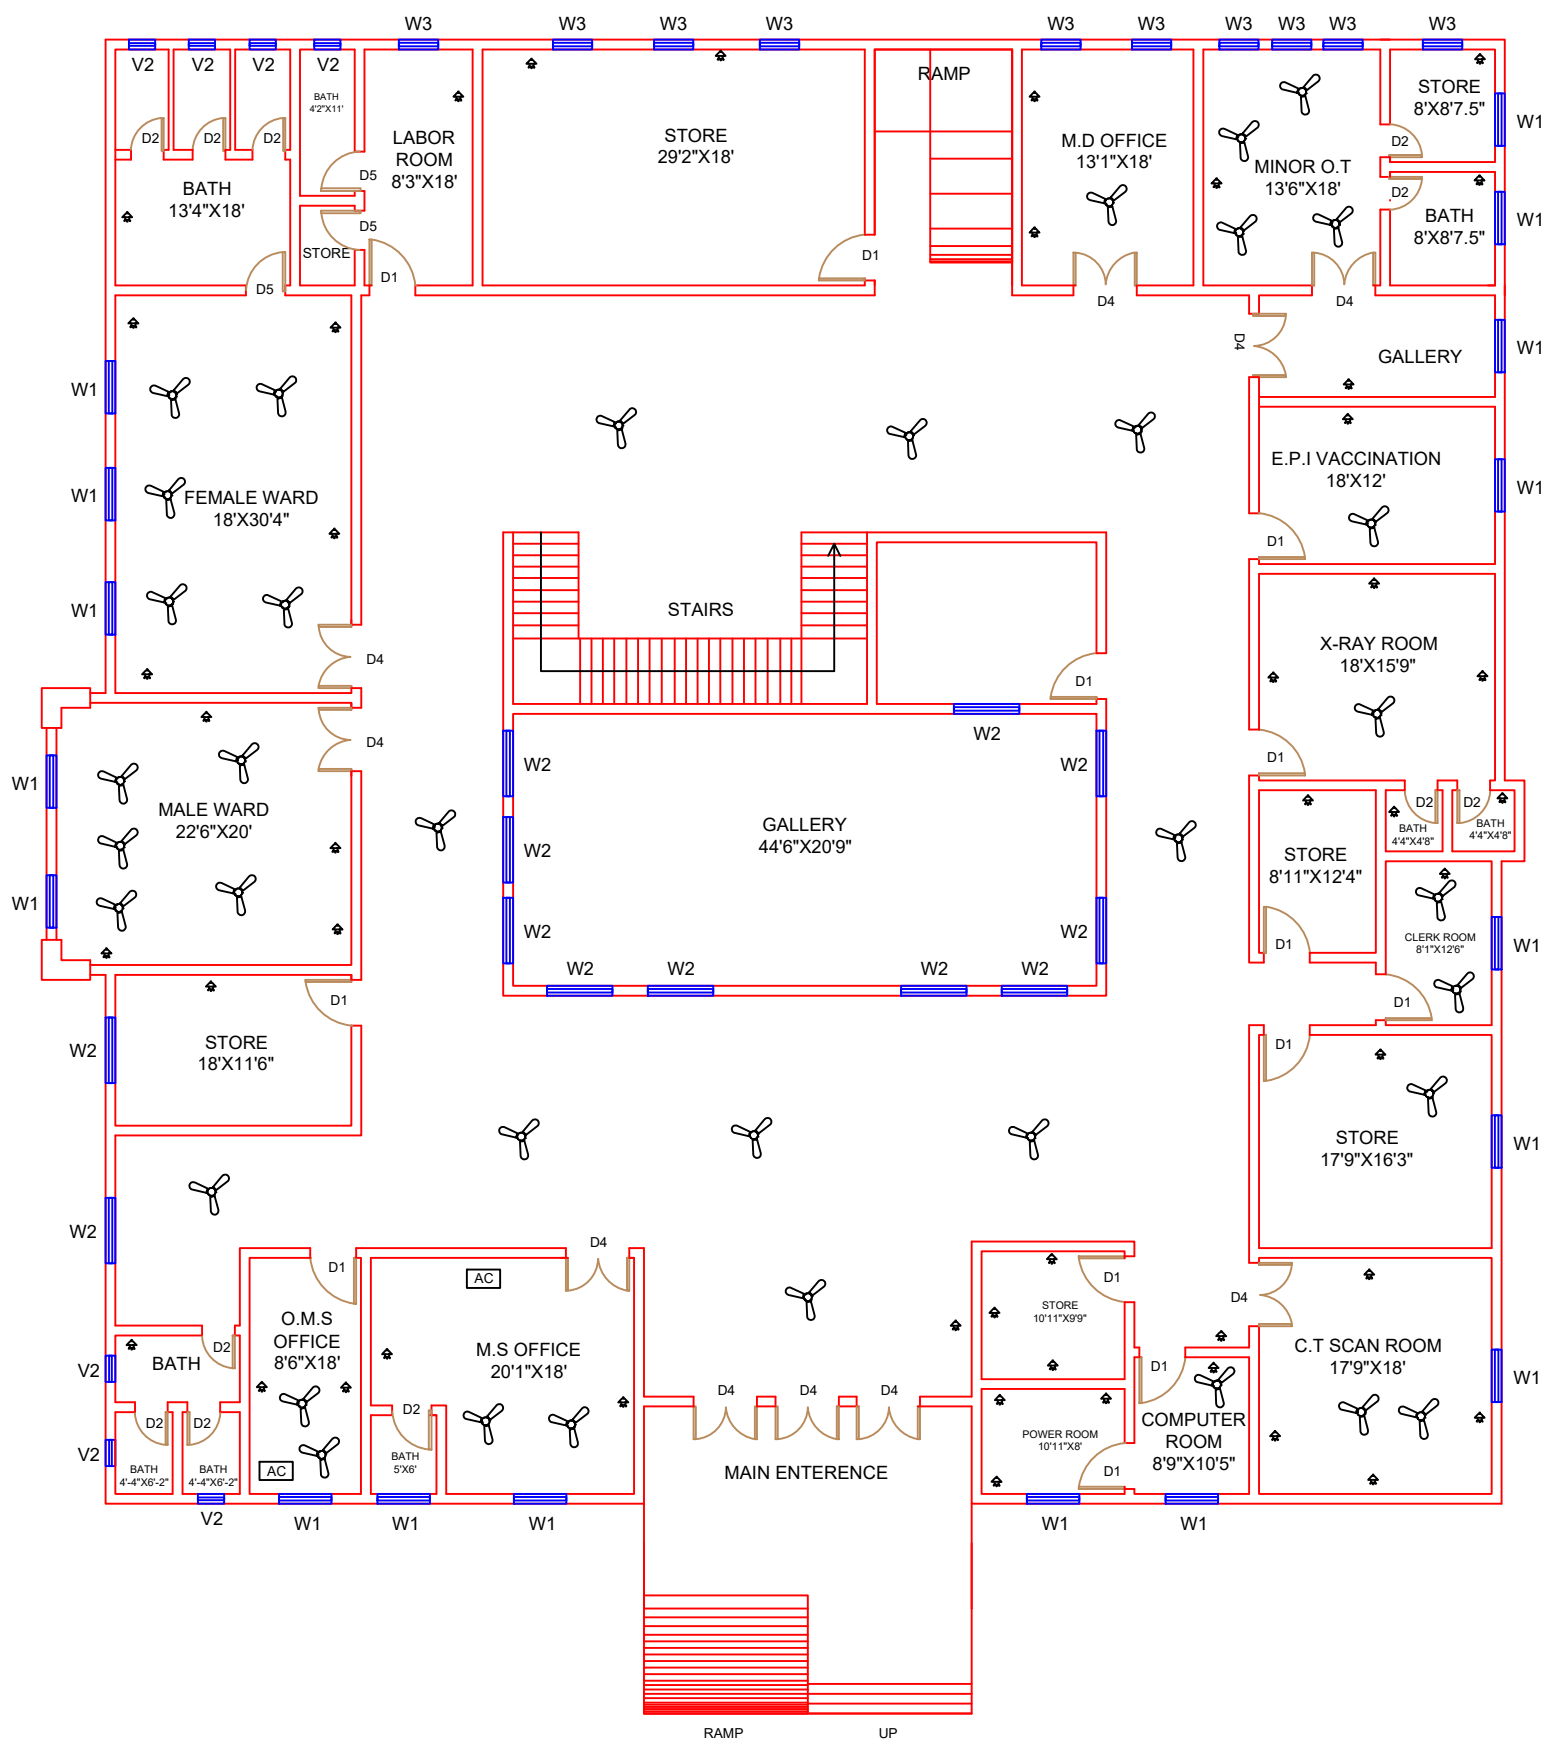

Legends:

Residential Area	
Road	
Wall	
Power Line	
OHT	
Tree	
Man Hole	
Tube Well	
Light Pole	
Lawns	
Earthen Areas	
Asphalts Roads	
Tough Pavers	
P.C.C / Plinth Protection	
Boundary Wall	
Brick Pavers / Soling	
Drain	
Tap	
Hand Pump	
Air Conditioner	
Tube Light	
Fan	
Roof Light	
Bulb	

AREA	
AREA WITHIN BOUNDARY WALL	99362.626 Sft
AREA OF CLINICAL BLOCK	24824.87 Sft
PLINTH AREA OF BLOCK	12412.435Sft

OPENING SCHEDULE OF DOORS AND WINDOWS					
DOORS	WIDTH	HEIGHT	WINDOWS	WIDTH	HEIGHT
D1	3'-6"	8'-3"	W1	4'-0"	5'-0"
D2	2'-6"	7'-0"	W2	5'-0"	3'-6"
D3	3'-0"	8'-3"	W3	6'-0"	5'-6"
D4	4'-10"	8'-3"	W4	3'-0"	8'-3"
D5	3'-0"	7'-0"	W5	6'-0"	7'-6"

Project: CAD MAPPING OF TEHSIL HEAD QUARTER HOSPITALS, PUNJAB


Client: GOVERNMENT OF THE PUNJAB PRIMARY & SECONDARY HEALTHCARE DEPARTMENT	Consultant: SKAFS CONSULTANT (Pvt.) Limited ENGINEERING AND ENVIRONMENT CONSULTANT
---	--

Drawing Title: THQ KALLAR KAHAR ELECTRICAL PLAN (GROUND FLOOR)

Drawing No. SKAFS/K-KAHAR /15

ELECTRICAL LAYOUT PLAN OF THQ HOSPITAL KALLAR KAHAR

FIRST FLOOR

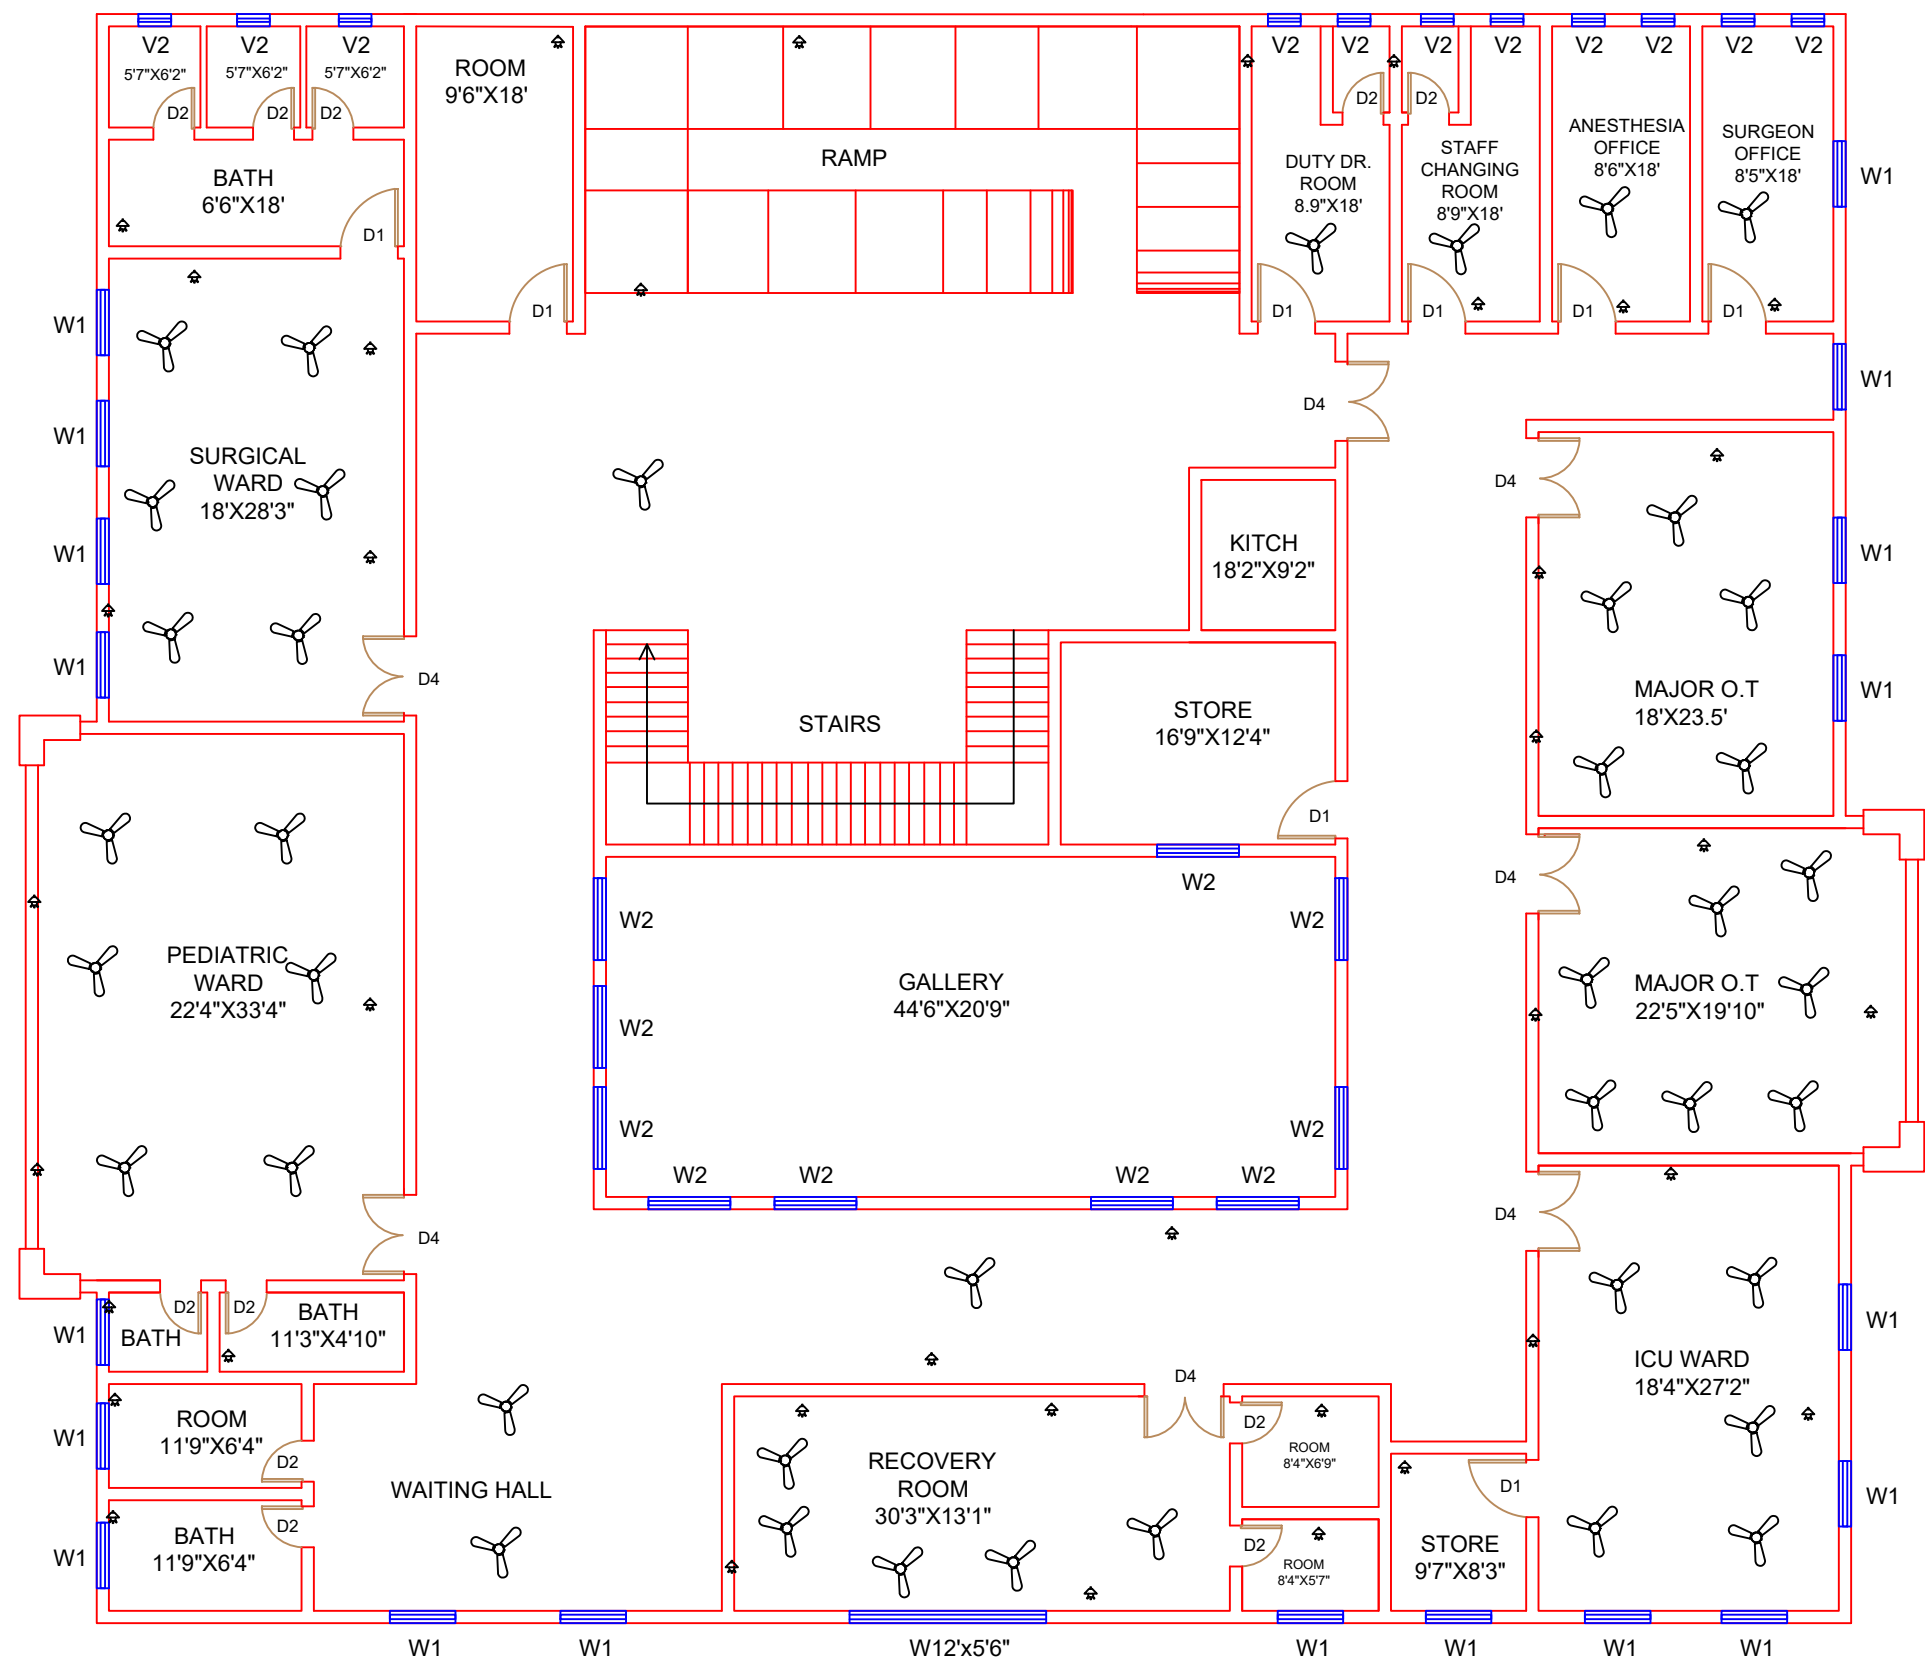

Legends:

Residential Area	
Road	
Wall	
Power Line	
OHT	
Tree	
Man Hole	
Tube Well	
Light Pole	
Lawns	
Earthen Areas	
Asphalts Roads	
Tough Pavers	
P.C.C / Plinth Protection	
Boundary Wall	
Brick Pavers / Soling	
Drain	
Tap	
Hand Pump	
Air Conditioner	
Tube Light	
Fan	
Roof Light	
Bulb	

AREA	
AREA WITHIN BOUNDARY WALL	99362.626 Sft
AREA OF CLINICAL BLOCK	24824.87 Sft
PLINTH AREA OF BLOCK	12412.435Sft

OPENING SCHEDULE OF DOORS AND WINDOWS					
DOORS	WIDTH	HEIGHT	WINDOWS	WIDTH	HEIGHT
D1	3'-6"	8'-3"	W1	4'-0"	5'-0"
D2	2'-6"	7'-0"	W2	5'-0"	3'-6"
D3	3'-0"	8'-3"	W3	6'-0"	5'-6"
D4	4'-10"	8'-3"	W4	3'-0"	8'-3"
D5	3'-0"	7'-0"	W5	6'-0"	7'-6"

Project: CAD MAPPING OF TEHSIL HEAD QUARTER HOSPITALS, PUNJAB

Client: GOVERNMENT OF THE PUNJAB PRIMARY & SECONDARY HEALTHCARE DEPARTMENT	Consultant: SKAFS CONSULTANT (Pvt.) Limited ENGINEERING AND ENVIRONMENT CONSULTANT
---	--

Drawing Title: THQ KALLAR KAHAR ELECTRICAL PLAN (FIRST FLOOR)

Drawing No. SKAFS/K-KAHAR /16