




MASTER PLAN OF THQ HOSPITAL KALLAR SYEDAN

PART 1

PART 2

PART 3

PART 4

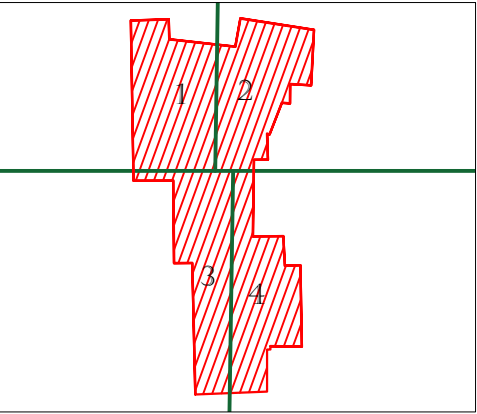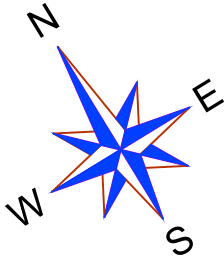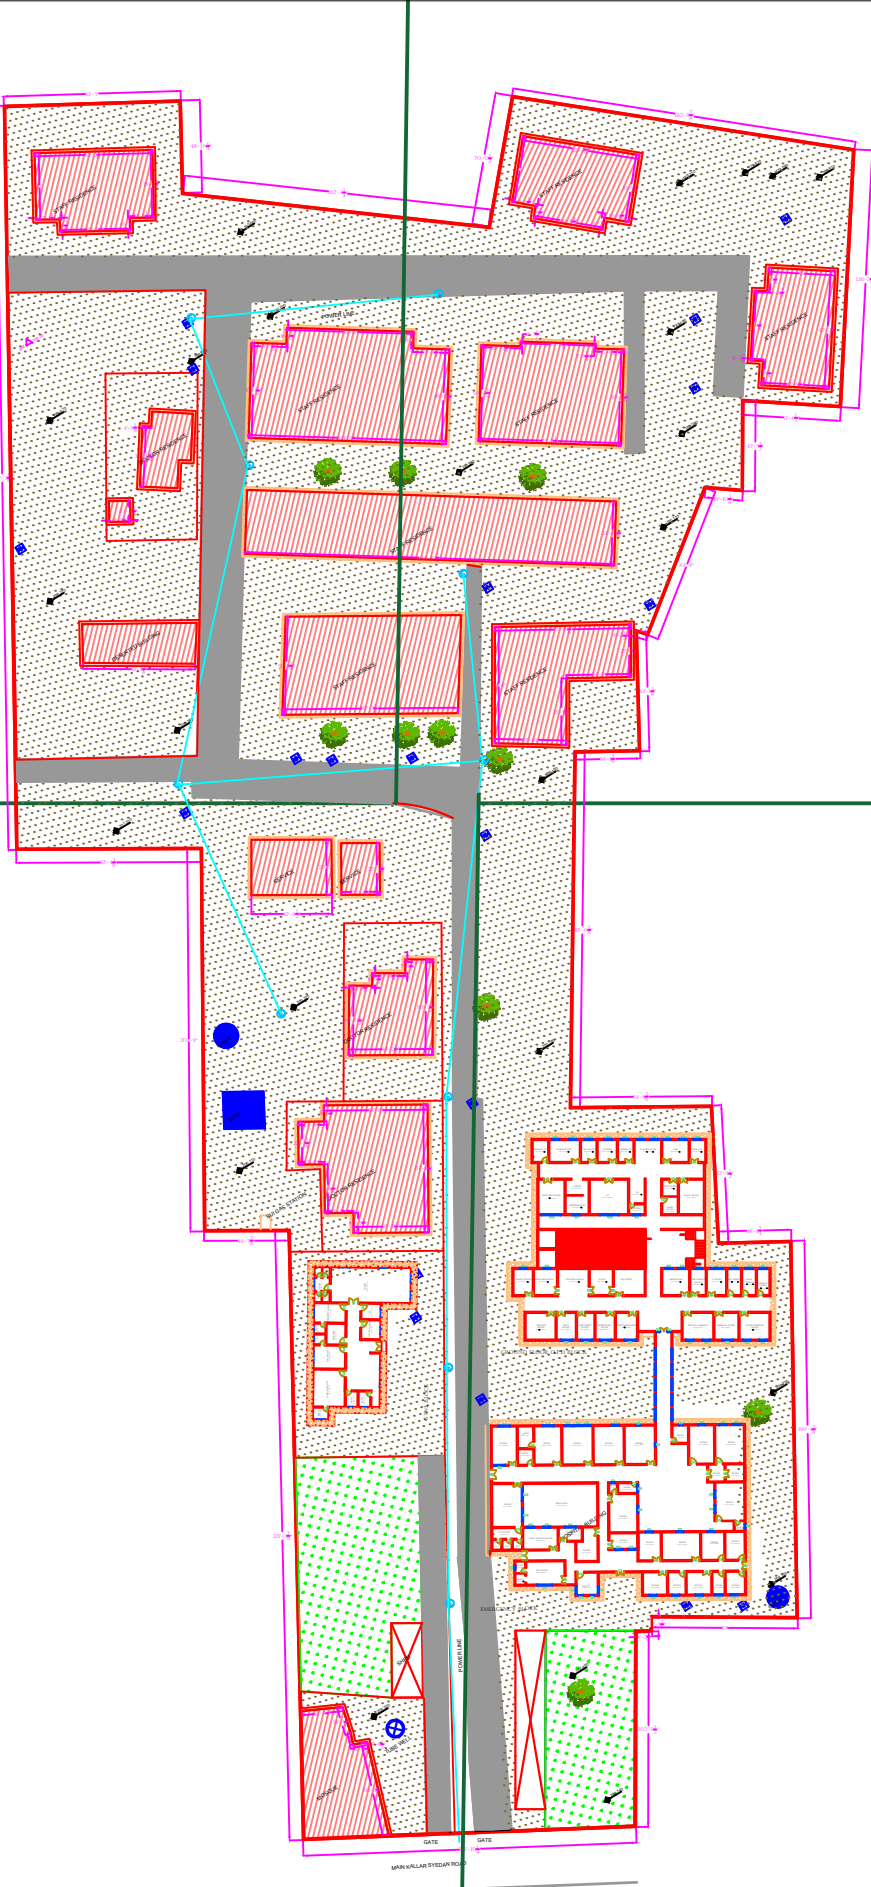

Legends:

RESIDENTIAL AREA	
ROAD	
WALL	
POWER LINE	
OHT	
TREE	
MAN HOLE	
TUBE WELL	
LIGHT POLE	
LAWNS	
EARTHEN AREAS	
ASPHALTS ROADS	
TOUGH PAVERS	
P.C.C / PLINTH	
BOUNDARY WALL	
BRICK PAVERS / SOLING	
DRAIN	
TAP	
HAND PUMP	
AIR CONDITIONER	
TUBE LIGHT	
FAN	
ROOF LIGHT	
BULB	

AREA	
AREA WITHIN BOUNDARY WALL	257503.46 SFT
AREA OF CLINICAL BLOCK	25776.25 SFT
PLINTH AREA OF BLOCK	17919.65 SFT

OPENING SCHEDULE OF DOORS AND WINDOWS					
DOORS	WIDTH	HEIGHT	WINDOWS	WIDTH	HEIGHT
D1	5'-6"	7'-0"	W1	3'-0"	3'-0"
D2	5'-0"	7'-0"	W2	3'-6"	3'-6"
D3	4'-0"	7'-0"	W3	6'-0"	6'-0"
D4	3'-6"	7'-0"	W4	4'-6"	4'-6"
D5	3'-0"	7'-0"	W5	8'-6"	8'-6"
D6	2'-6"	7'-0"	W7	2'-6"	2'-6"
D7	6'-0"	7'-0"	W8	4'-0"	4'-0"
V1	1'-6"	1'-6"	W9	5'-0"	5'-0"
V2	2'-0"	2'-0"	W10	7'-0"	7'-0"

Project:
CAD MAPPING OF TEHSIL HEAD QUARTER HOSPITALS, PUNJAB

Client:
GOVERNMENT OF THE PUNJAB
PRIMARY & SECONDARY HEALTHCARE DEPARTMENT



Consultant:
SKAFS CONSULTANT (Pvt.) Limited
ENGINEERING AND ENVIRONMENT CONSULTANT

Drawing Title:
THQ KALLAR SYEDAN HOSPITAL MASTER PLAN

Drawing No.:
SKAFS/KALLAR.SYD/03

MASTER PLAN OF THQ HOSPITAL KALLAR SYEDAN

PART 1

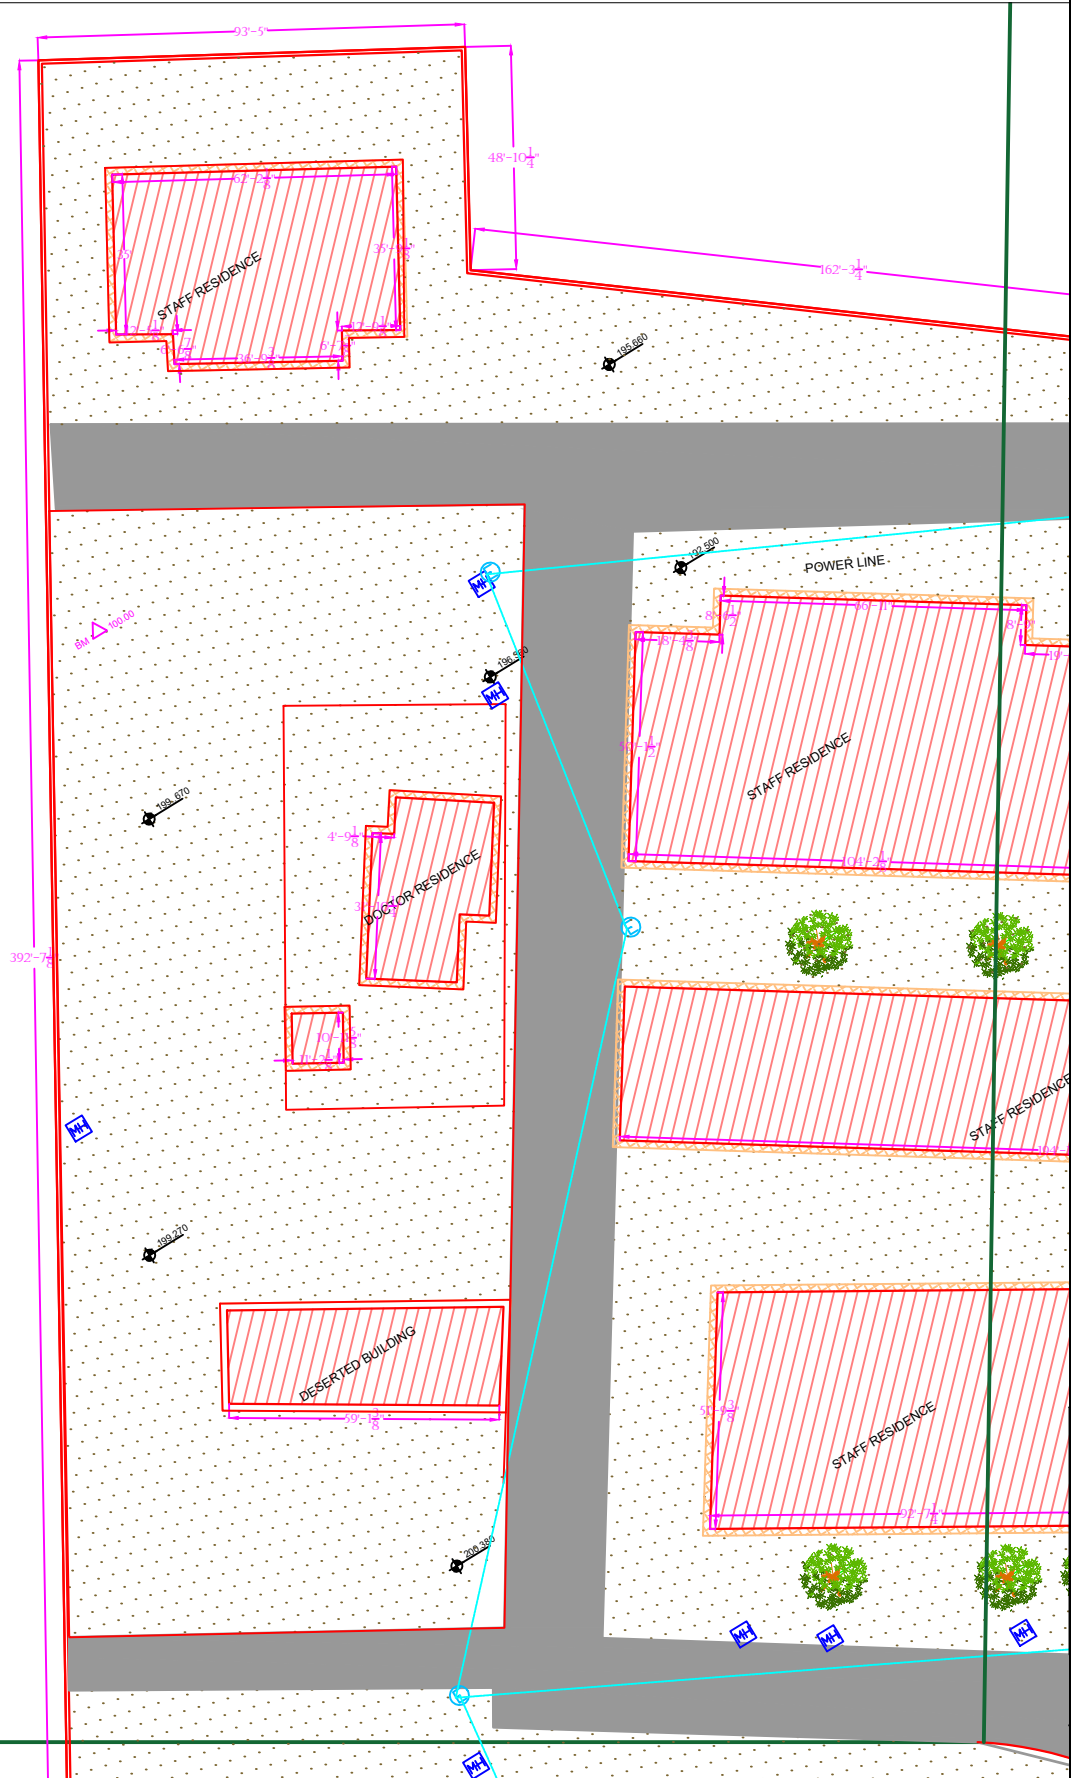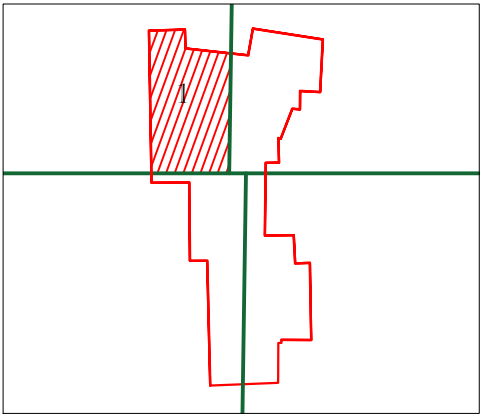

Legends:

RESIDENTIAL AREA	
ROAD	
WALL	
POWER LINE	
OHT	
TREE	
MAN HOLE TUBE WELL	
LIGHT POLE	
LAWNS	
EARTHEN AREAS	
ASPHALTS ROADS	
TOUGH PAVERS	
P.C.C / PLINTH	
BOUNDARY WALL	
BRICK PAVERS / SOLING	
DRAIN	
TAP	
HAND PUMP	
AIR CONDITIONER	
TUBE LIGHT	
FAN	
ROOF LIGHT	
BULB	

AREA	
AREA WITHIN BOUNDARY WALL	257503.46 SFT
AREA OF CLINICAL BLOCK	25776.25 SFT
PLINTH AREA OF BLOCK	17919.65 SFT

OPENING SCHEDULE OF DOORS AND WINDOWS					
DOORS	WIDTH	HEIGHT	WINDOWS	WIDTH	HEIGHT
D1	5'-6"	7'-0"	W1	3'-0"	3'-0"
D2	5'-0"	7'-0"	W2	3'-6"	3'-6"
D3	4'-0"	7'-0"	W3	6'-0"	6'-0"
D4	3'-6"	7'-0"	W4	4'-6"	4'-6"
D5	3'-0"	7'-0"	W5	8'-6"	8'-6"
D6	2'-6"	7'-0"	W7	2'-6"	2'-6"
D7	6'-0"	7'-0"	W8	4'-0"	4'-0"
V1	1'-6"	1'-6"	W9	5'-0"	5'-0"
V2	2'-0"	2'-0"	W10	7'-0"	7'-0"

Project:
**CAD MAPPING OF TEHSIL
HEAD QUARTER HOSPITALS,
PUNJAB**




Client: GOVERNMENT OF THE PUNJAB PRIMARY & SECONDARY HEALTHCARE DEPARTMENT	Consultant: SKAFS CONSULTANT (Pvt.) Limited ENGINEERING AND ENVIRONMENT CONSULTANT
---	--

Drawing Title:
**THQ KALLAR SYEDAN
HOSPITAL MASTER PLAN PART 1**

Drawing No.
SKAFS/KALLAR.SYD/04

MASTER PLAN OF THQ HOSPITAL KALLAR SYEDAN

PART 2

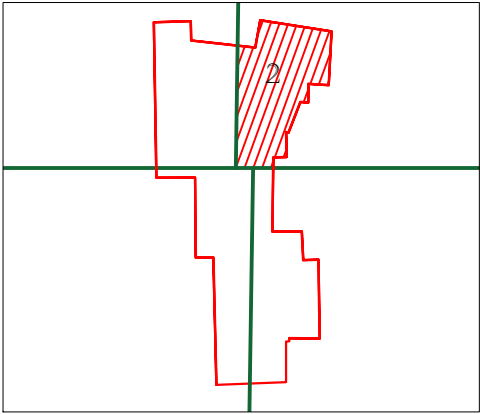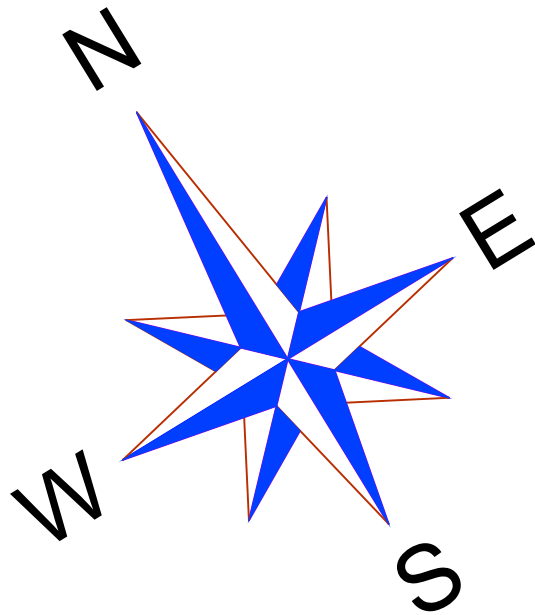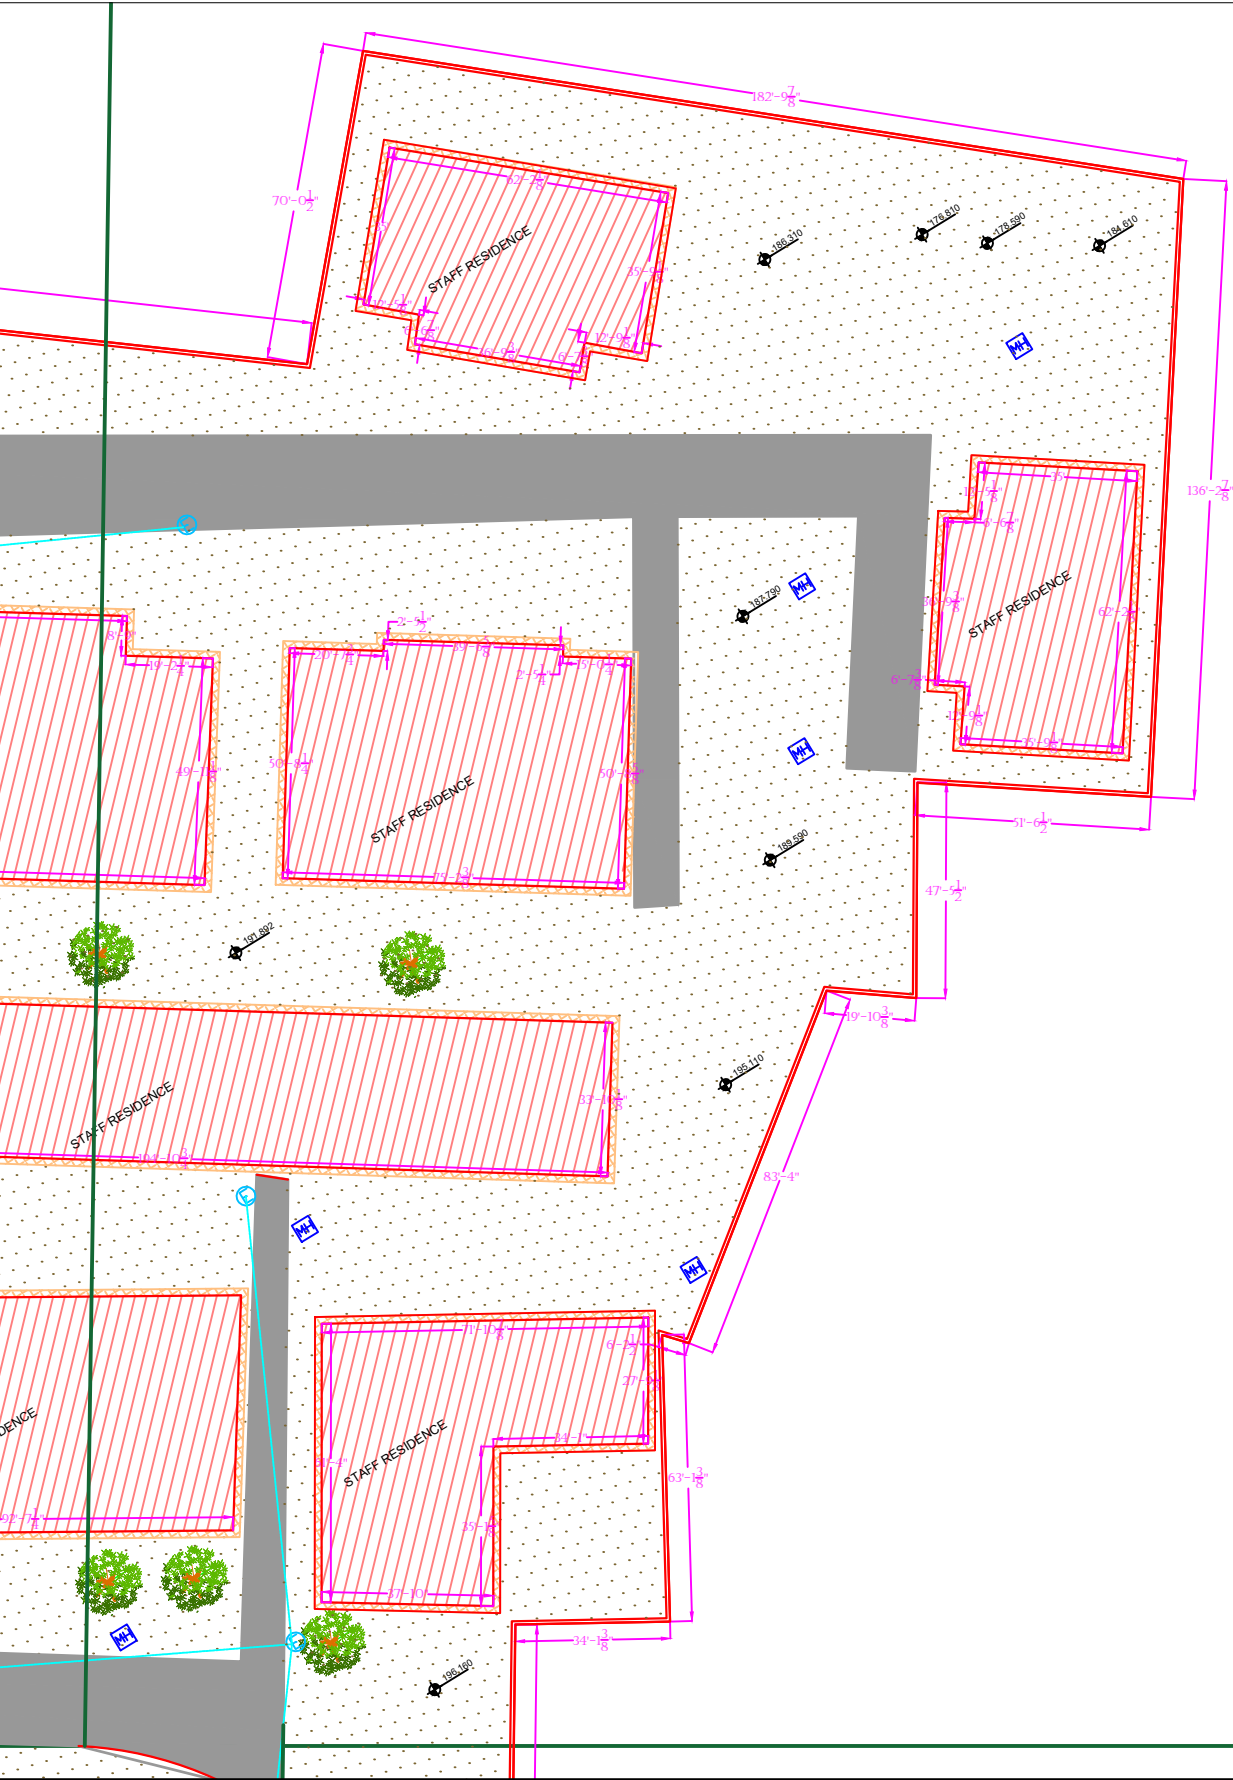

Legends:

RESIDENTIAL AREA	
ROAD	
WALL	
POWER LINE	
OHT	
TREE	
MAN HOLE	
TUBE WELL	
LIGHT POLE	
LAWNS	
EARTHEN AREAS	
ASPHALTS ROADS	
TOUGH PAVERS	
P.C.C / PLINTH	
BOUNDARY WALL	
BRICK PAVERS / SOLING	
DRAIN	
TAP	
HAND PUMP	
AIR CONDITIONER	
TUBE LIGHT	
FAN	
ROOF LIGHT	
BULB	

AREA	
AREA WITHIN BOUNDARY WALL	257503.46 SFT
AREA OF CLINICAL BLOCK	25776.25 SFT
PLINTH AREA OF BLOCK	17919.65 SFT

OPENING SCHEDULE OF DOORS AND WINDOWS					
DOORS	WIDTH	HEIGHT	WINDOWS	WIDTH	HEIGHT
D1	5'-6"	7'-0"	W1	3'-0"	3'-0"
D2	5'-0"	7'-0"	W2	3'-6"	3'-6"
D3	4'-0"	7'-0"	W3	6'-0"	6'-0"
D4	3'-6"	7'-0"	W4	4'-6"	4'-6"
D5	3'-0"	7'-0"	W5	8'-6"	8'-6"
D6	2'-6"	7'-0"	W7	2'-6"	2'-6"
D7	6'-0"	7'-0"	W8	4'-0"	4'-0"
V1	1'-6"	1'-6"	W9	5'-0"	5'-0"
V2	2'-0"	2'-0"	W10	7'-0"	7'-0"

Project:

CAD MAPPING OF TEHSIL HEAD QUARTER HOSPITALS, PUNJAB

Client:	Consultant:
 GOVERNMENT OF THE PUNJAB PRIMARY & SECONDARY HEALTHCARE DEPARTMENT	 SKAFS CONSULTANT (Pvt.) Limited ENGINEERING AND ENVIRONMENT CONSULTANT

Drawing Title:



**THQ KALLAR SYEDAN
HOSPITAL MASTER PLAN PART 2**

Drawing No.

SKAFS/KALLAR.SYD/05

MASTER PLAN OF THQ HOSPITAL KALLAR SYEDAN

PART 3

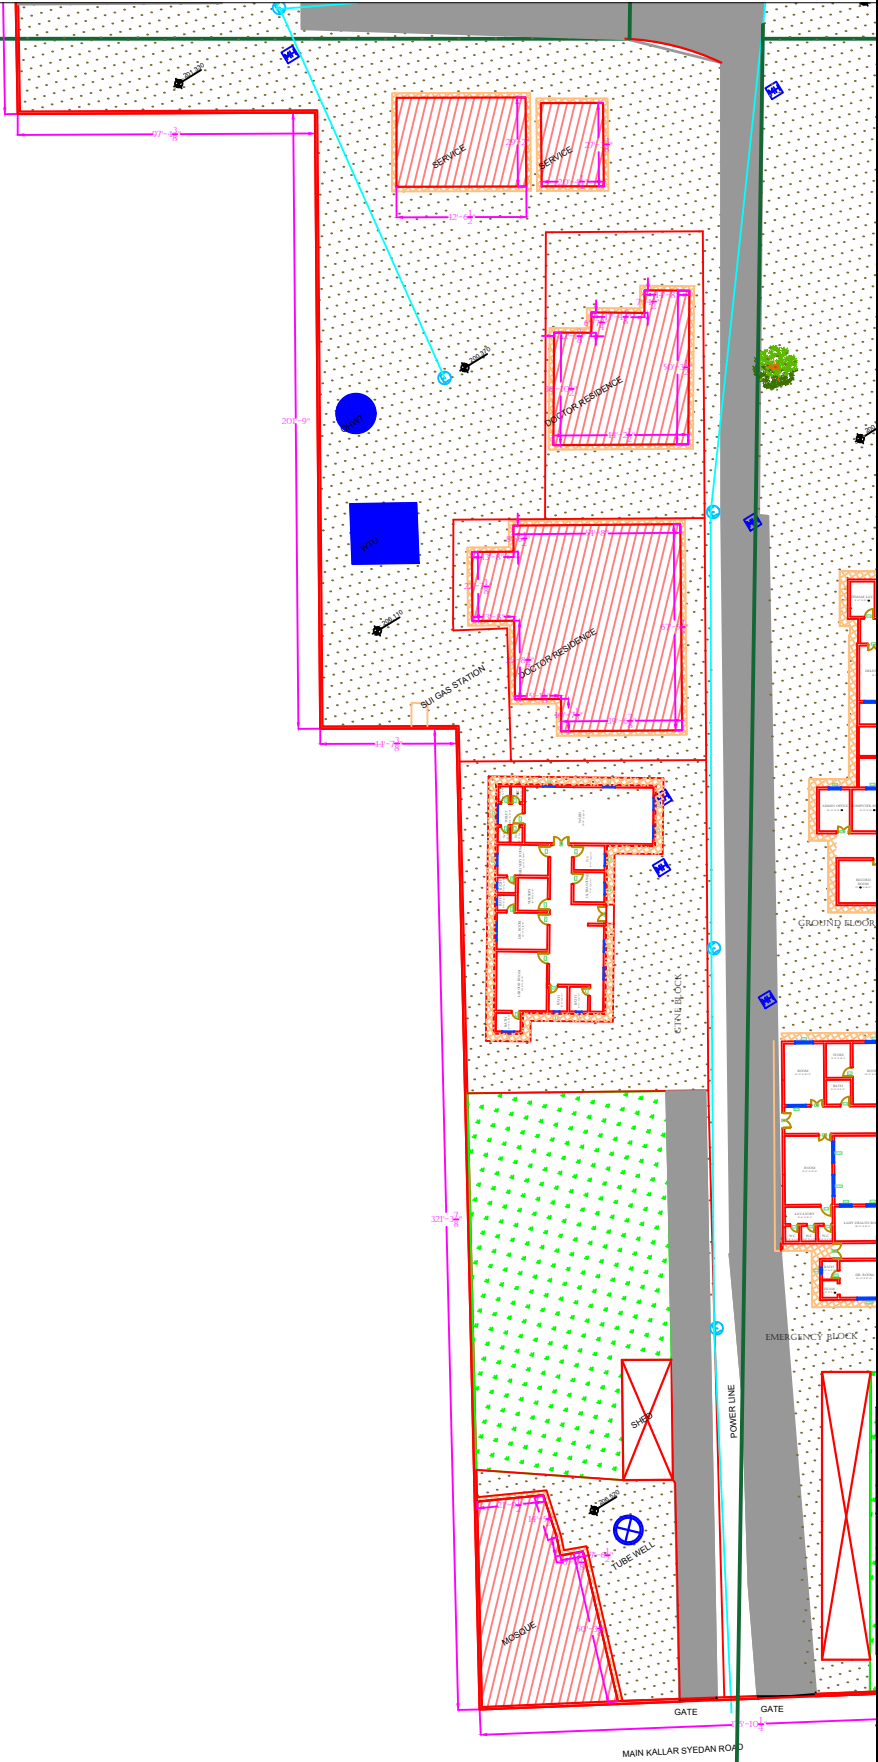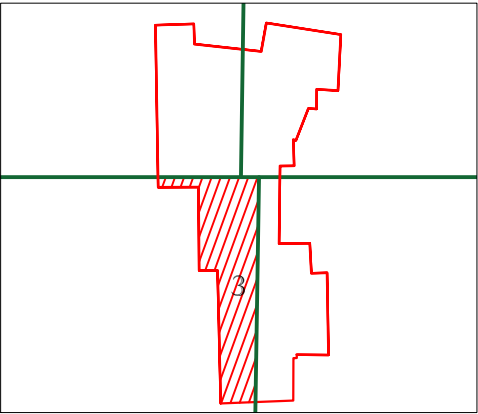

Legends:

RESIDENTIAL AREA	
ROAD	
WALL	
POWER LINE	
OHT	
TREE	
MAN HOLE	
TUBE WELL	
LIGHT POLE	
LAWNS	
EARTHEN AREAS	
ASPHALTS ROADS	
TOUGH PAVERS	
P.C.C / PLINTH	
BOUNDARY WALL	
BRICK PAVERS / SOLING	
DRAIN	
TAP	
HAND PUMP	
AIR CONDITIONER	
TUBE LIGHT	
FAN	
ROOF LIGHT	
BULB	

AREA	
AREA WITHIN BOUNDARY WALL	257503.46 SFT
AREA OF CLINICAL BLOCK	25776.25 SFT
PLINTH AREA OF BLOCK	17919.65 SFT

OPENING SCHEDULE OF DOORS AND WINDOWS					
DOORS	WIDTH	HEIGHT	WINDOWS	WIDTH	HEIGHT
D1	5'-6"	7'-0"	W1	3'-0"	3'-0"
D2	5'-0"	7'-0"	W2	3'-6"	3'-6"
D3	4'-0"	7'-0"	W3	6'-0"	6'-0"
D4	3'-6"	7'-0"	W4	4'-6"	4'-6"
D5	3'-0"	7'-0"	W5	8'-6"	8'-6"
D6	2'-6"	7'-0"	W7	2'-6"	2'-6"
D7	6'-0"	7'-0"	W8	4'-0"	4'-0"
V1	1'-6"	1'-6"	W9	5'-0"	5'-0"
V2	2'-0"	2'-0"	W10	7'-0"	7'-0"

Project:

CAD MAPPING OF TEHSIL HEAD QUARTER HOSPITALS, PUNJAB

Client:

GOVERNMENT OF THE PUNJAB
PRIMARY & SECONDARY
HEALTHCARE DEPARTMENT

Consultant:

SKAFS CONSULTANT (Pvt.)
Limited
ENGINEERING AND ENVIRONMENT
CONSULTANT

Drawing Title:


**THQ KALLAR SYEDAN
HOSPITAL MASTER PLAN PART 3**

Drawing No.

SKAFS/KALLAR.SYD/06

MASTER PLAN OF THQ HOSPITAL KALLAR SYEDAN

PART 4

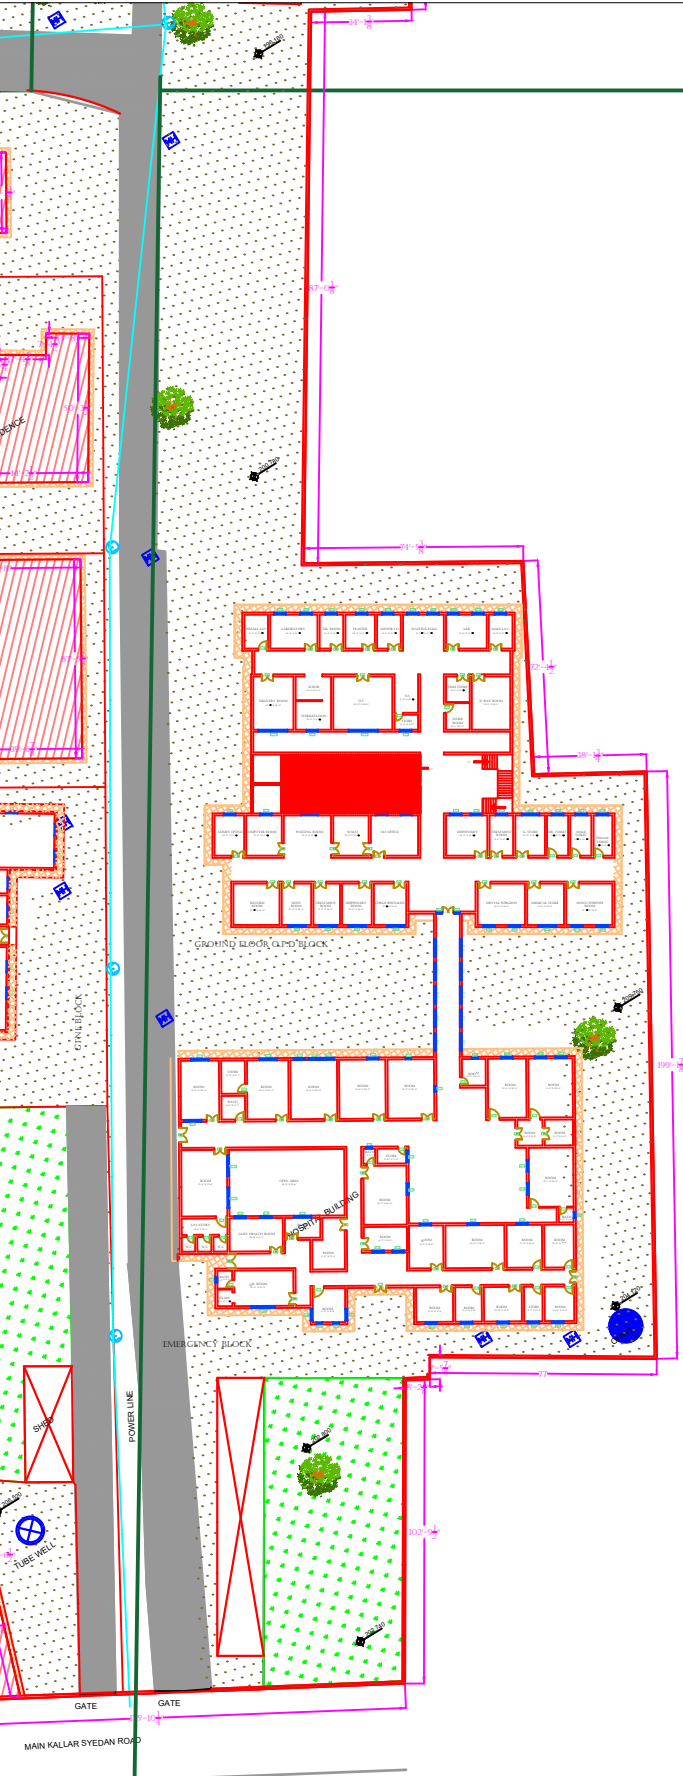

Legends:

RESIDENTIAL AREA	
ROAD	
WALL	
POWER LINE	
OHT	
TREE	
MAN HOLE	
TUBE WELL	
LIGHT POLE	
LAWNS	
EARTHEN AREAS	
ASPHALTS ROADS	
TOUGH PAVERS	
P.C.C / PLINTH	
BOUNDARY WALL	
BRICK PAVERS / SOLING	
DRAIN	
TAP	
HAND PUMP	
AIR CONDITIONER	
TUBE LIGHT	
FAN	
ROOF LIGHT	
BULB	

AREA	
AREA WITHIN BOUNDARY WALL	257503.46 SFT
AREA OF CLINICAL BLOCK	25776.25 SFT
PLINTH AREA OF BLOCK	17919.65 SFT


OPENING SCHEDULE OF DOORS AND WINDOWS					
DOORS	WIDTH	HEIGHT	WINDOWS	WIDTH	HEIGHT
D1	5'-6"	7'-0"	W1	3'-0"	3'-0"
D2	5'-0"	7'-0"	W2	3'-6"	3'-6"
D3	4'-0"	7'-0"	W3	6'-0"	6'-0"
D4	3'-6"	7'-0"	W4	4'-6"	4'-6"
D5	3'-0"	7'-0"	W5	8'-6"	8'-6"
D6	2'-6"	7'-0"	W7	2'-6"	2'-6"
D7	6'-0"	7'-0"	W8	4'-0"	4'-0"
V1	1'-6"	1'-6"	W9	5'-0"	5'-0"
V2	2'-0"	2'-0"	W10	7'-0"	7'-0"

Project:
CAD MAPPING OF TEHSIL HEAD QUARTER HOSPITALS, PUNJAB

Client: GOVERNMENT OF THE PUNJAB PRIMARY & SECONDARY HEALTHCARE DEPARTMENT	Consultant: SKAFS CONSULTANT (Pvt.) Limited ENGINEERING AND ENVIRONMENT CONSULTANT
---	--

Drawing Title:
**THQ KALLAR SYEDAN
HOSPITAL MASTER PLAN PART 4**


Drawing No.
SKAFS/KALLAR.SYD/07

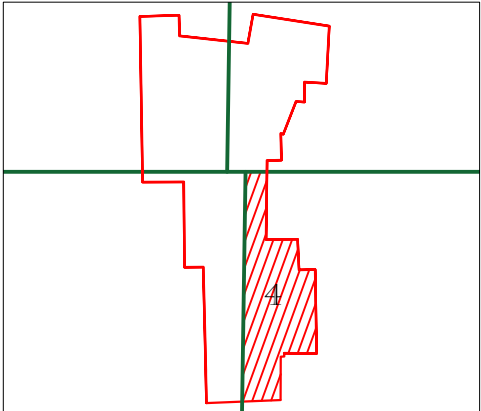

CLINICAL BLOCK OF THQ HOSPITAL KALLAR SYEDAN

GROUND FLOOR

PART 1

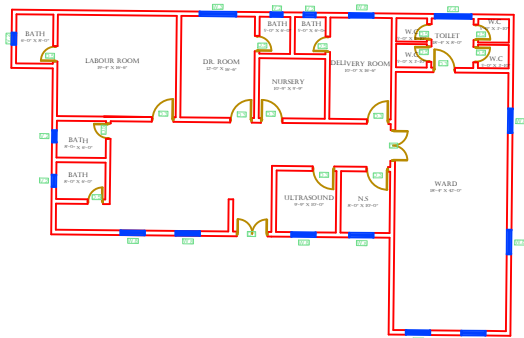


GYNEA BLOCK

PART 2



GROUND FLOOR O.P.D BLOCK

PART 3

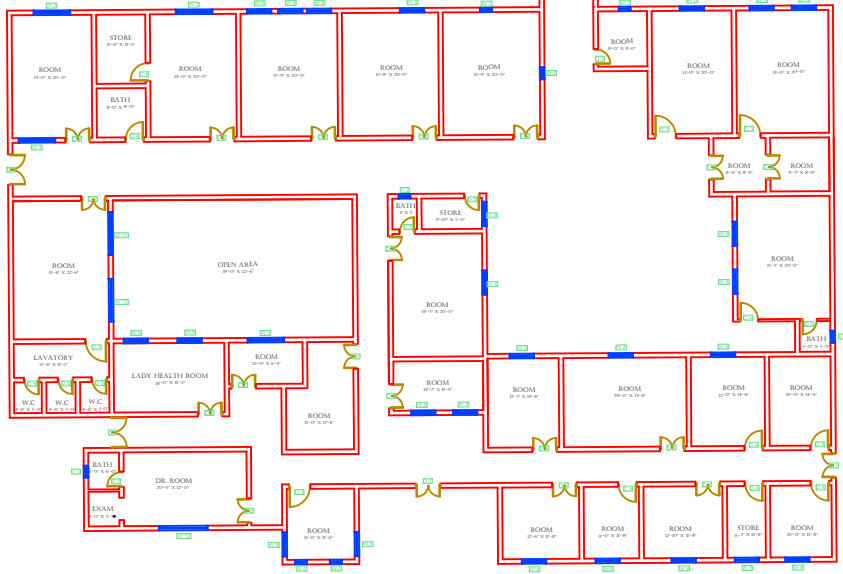

EMERGENCY BLOCK

Legends:

RESIDENTIAL AREA

ROAD

WALL

POWER LINE

OHT

TREE

MAN HOLE

TUBE WELL

LIGHT POLE

LAWNS

EARTHEN AREAS

ASPHALTS ROADS

TOUGH PAVERS

P.C.C / PLINTH

BOUNDARY WALL

BRICK PAVERS / SOLING

DRAIN

TAP

HAND PUMP

AIR CONDITIONER

TUBE LIGHT

FAN

ROOF LIGHT

BULB

AREA	
AREA WITHIN BOUNDARY WALL	257503.46 SFT
AREA OF CLINICAL BLOCK	25776.25 SFT
PLINTH AREA OF BLOCK	17919.65 SF1

OPENING SCHEDULE OF DOORS AND WINDOWS					
DOORS	WIDTH	HEIGHT	WINDOWS	WIDTH	HEIGHT
D1	5'-6"	7'-0"	W1	3'-0"	3'-0"
D2	5'-0"	7'-0"	W2	3'-6"	3'-6"
D3	4'-0"	7'-0"	W3	6'-0"	6'-0"
D4	3'-6"	7'-0"	W4	4'-6"	4'-6"
D5	3'-0"	7'-0"	W5	8'-6"	8'-6"
D6	2'-6"	7'-0"	W7	2'-6"	2'-6"
D7	6'-0"	7'-0"	W8	4'-0"	4'-0"
V1	1'-6"	1'-6"	W9	5'-0"	5'-0"
V2	2'-0"	2'-0"	W10	7'-0"	7'-0"

Project:
CAD MAPPING OF TEHSIL HEAD QUARTER HOSPITALS, PUNJAB

Client:

GOVERNMENT OF THE PUNJAB
PRIMARY & SECONDARY
HEALTHCARE DEPARTMENT

Consultant:


SKAFS CONSULTANT (Pvt.)
Limited
ENGINEERING AND ENVIRONMENT
CONSULTANT

Drawing Title:
THQ KALLAR SYEDAN HOSPITAL CLINICAL BLOCK PLAN

Drawing No.
SKAFS/KALLAR.SYD/08

CLINICAL BLOCK OF THQ HOSPITAL KALLAR SYEDAN

GROUND FLOOR PART 1

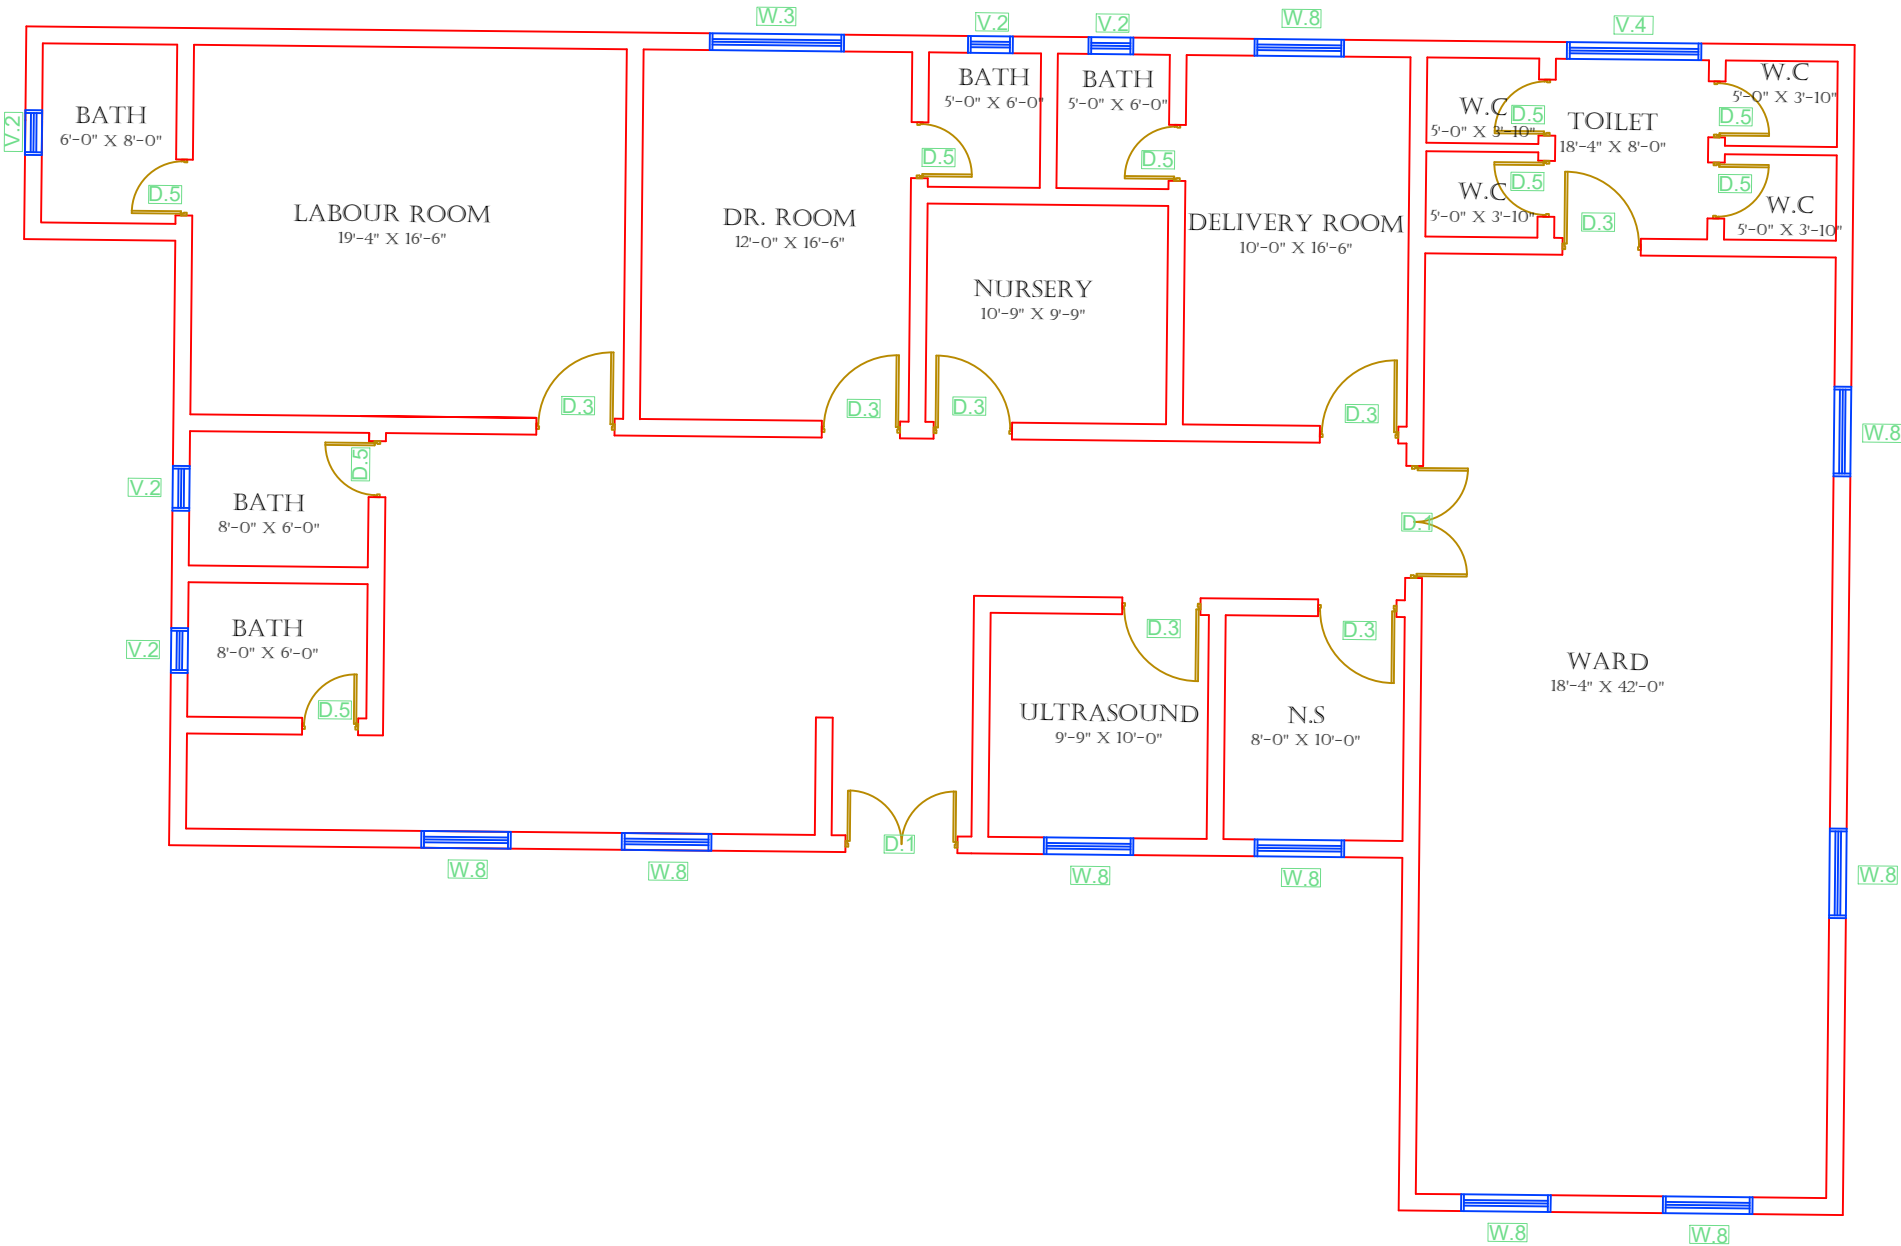

GYNEA BLOCK

Legends:	
RESIDENTIAL AREA	
ROAD	
WALL	
POWER LINE	
OHT	
TREE	
MAN HOLE	
TUBE WELL	
LIGHT POLE	
LAWNS	
EARTHEN AREAS	
ASPHALT'S ROADS	
TOUGH PAVERS	
P.C.C / PLINTH	
BOUNDARY WALL	
BRICK PAVERS / SOLING	
DRAIN	
TAP	
HAND PUMP	
AIR CONDITIONER	
TUBE LIGHT	
FAN	
ROOF LIGHT	
BULB	

AREA	
AREA WITHIN BOUNDARY WALL	257503.46 SFT
AREA OF CLINICAL BLOCK	25776.25 SFT
PLINTH AREA OF BLOCK	17919.65 SFT

OPENING SCHEDULE OF DOORS AND WINDOWS					
DOORS	WIDTH	HEIGHT	WINDOWS	WIDTH	HEIGHT
D1	5'-6"	7'-0"	W1	3'-0"	3'-0"
D2	5'-0"	7'-0"	W2	3'-6"	3'-6"
D3	4'-0"	7'-0"	W3	6'-0"	6'-0"
D4	3'-6"	7'-0"	W4	4'-6"	4'-6"
D5	3'-0"	7'-0"	W5	8'-6"	8'-6"
D6	2'-6"	7'-0"	W7	2'-6"	2'-6"
D7	6'-0"	7'-0"	W8	4'-0"	4'-0"
V1	1'-6"	1'-6"	W9	5'-0"	5'-0"
V2	2'-0"	2'-0"	W10	7'-0"	7'-0"

Project:
CAD MAPPING OF TEHSIL HEAD QUARTER HOSPITALS, PUNJAB


Client: GOVERNMENT OF THE PUNJAB PRIMARY & SECONDARY HEALTHCARE DEPARTMENT	Consultant: SKAFS CONSULTANT (Pvt.) Limited ENGINEERING AND ENVIRONMENT CONSULTANT
---	--

Drawing Title:
**THQ KALLAR SYEDAN
CLINICAL BLOCK PLAN (PART 1)**

Drawing No.
SKAFS/KALLAR.SYD/09

CLINICAL BLOCK OF THQ HOSPITAL KALLAR SYEDAN

GROUND FLOOR PART 2

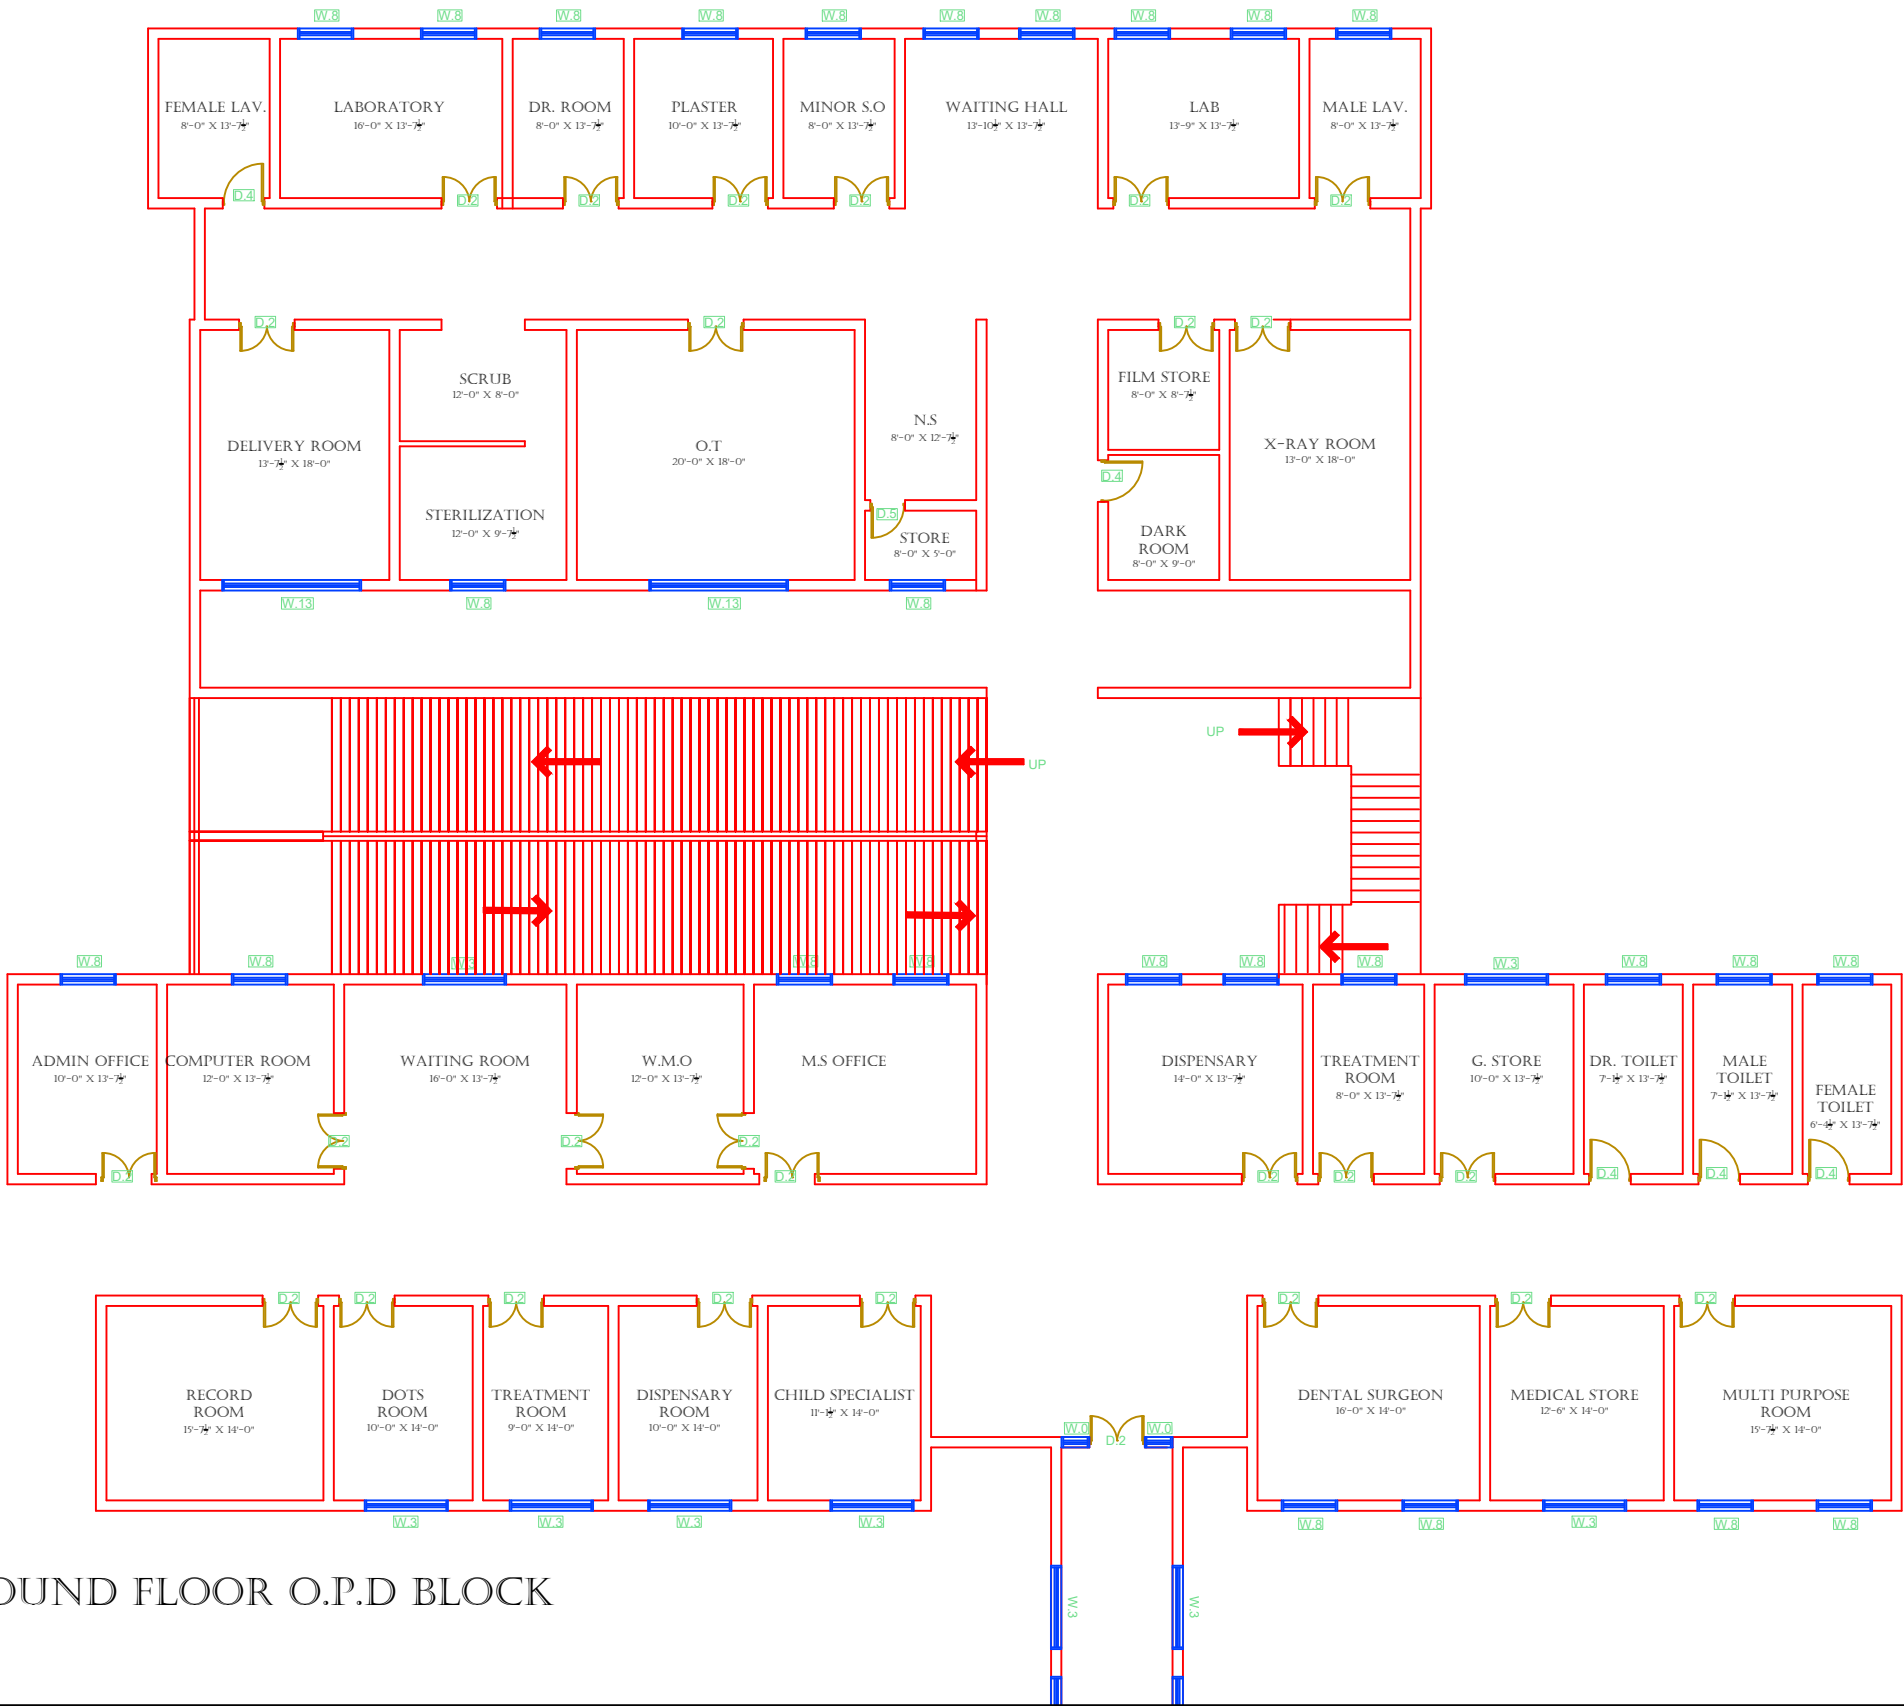

Legends:

RESIDENTIAL AREA	
ROAD	
WALL	
POWER LINE	
OHT	
TREE	
MAN HOLE	
TUBE WELL	
LIGHT POLE	
LAWNS	
EARTHEN AREAS	
ASPHALTS ROADS	
TOUGH PAVERS	
P.C.C / PLINTH	
BOUNDARY WALL	
BRICK PAVERS / SOLING	
DRAIN	
TAP	
HAND PUMP	
AIR CONDITIONER	
TUBE LIGHT	
FAN	
ROOF LIGHT	
BULB	

AREA	
AREA WITHIN BOUNDARY WALL	257503.46 SFT
AREA OF CLINICAL BLOCK	25776.25 SFT
PLINTH AREA OF BLOCK	17919.65 SFT

OPENING SCHEDULE OF DOORS AND WINDOWS					
DOORS	WIDTH	HEIGHT	WINDOWS	WIDTH	HEIGHT
D1	5'-6"	7'-0"	W1	3'-0"	3'-0"
D2	5'-0"	7'-0"	W2	3'-6"	3'-6"
D3	4'-0"	7'-0"	W3	6'-0"	6'-0"
D4	3'-6"	7'-0"	W4	4'-6"	4'-6"
D5	3'-0"	7'-0"	W5	8'-6"	8'-6"
D6	2'-6"	7'-0"	W7	2'-6"	2'-6"
D7	6'-0"	7'-0"	W8	4'-0"	4'-0"
V1	1'-6"	1'-6"	W9	5'-0"	5'-0"
V2	2'-0"	2'-0"	W10	7'-0"	7'-0"

Project:
CAD MAPPING OF TEHSIL HEAD QUARTER HOSPITALS, PUNJAB


Client: GOVERNMENT OF THE PUNJAB PRIMARY & SECONDARY HEALTHCARE DEPARTMENT	Consultant: SKAFS CONSULTANT (Pvt.) Limited ENGINEERING AND ENVIRONMENT CONSULTANT
---	--

Drawing Title:
**THQ KALLAR SYEDAN
CLINICAL BLOCK PLAN (PART 2)**

Drawing No.
SKAFS/KALLAR.SYD/10

CLINICAL BLOCK OF THQ HOSPITAL KALLAR SYEDAN

GROUND FLOOR PART 3

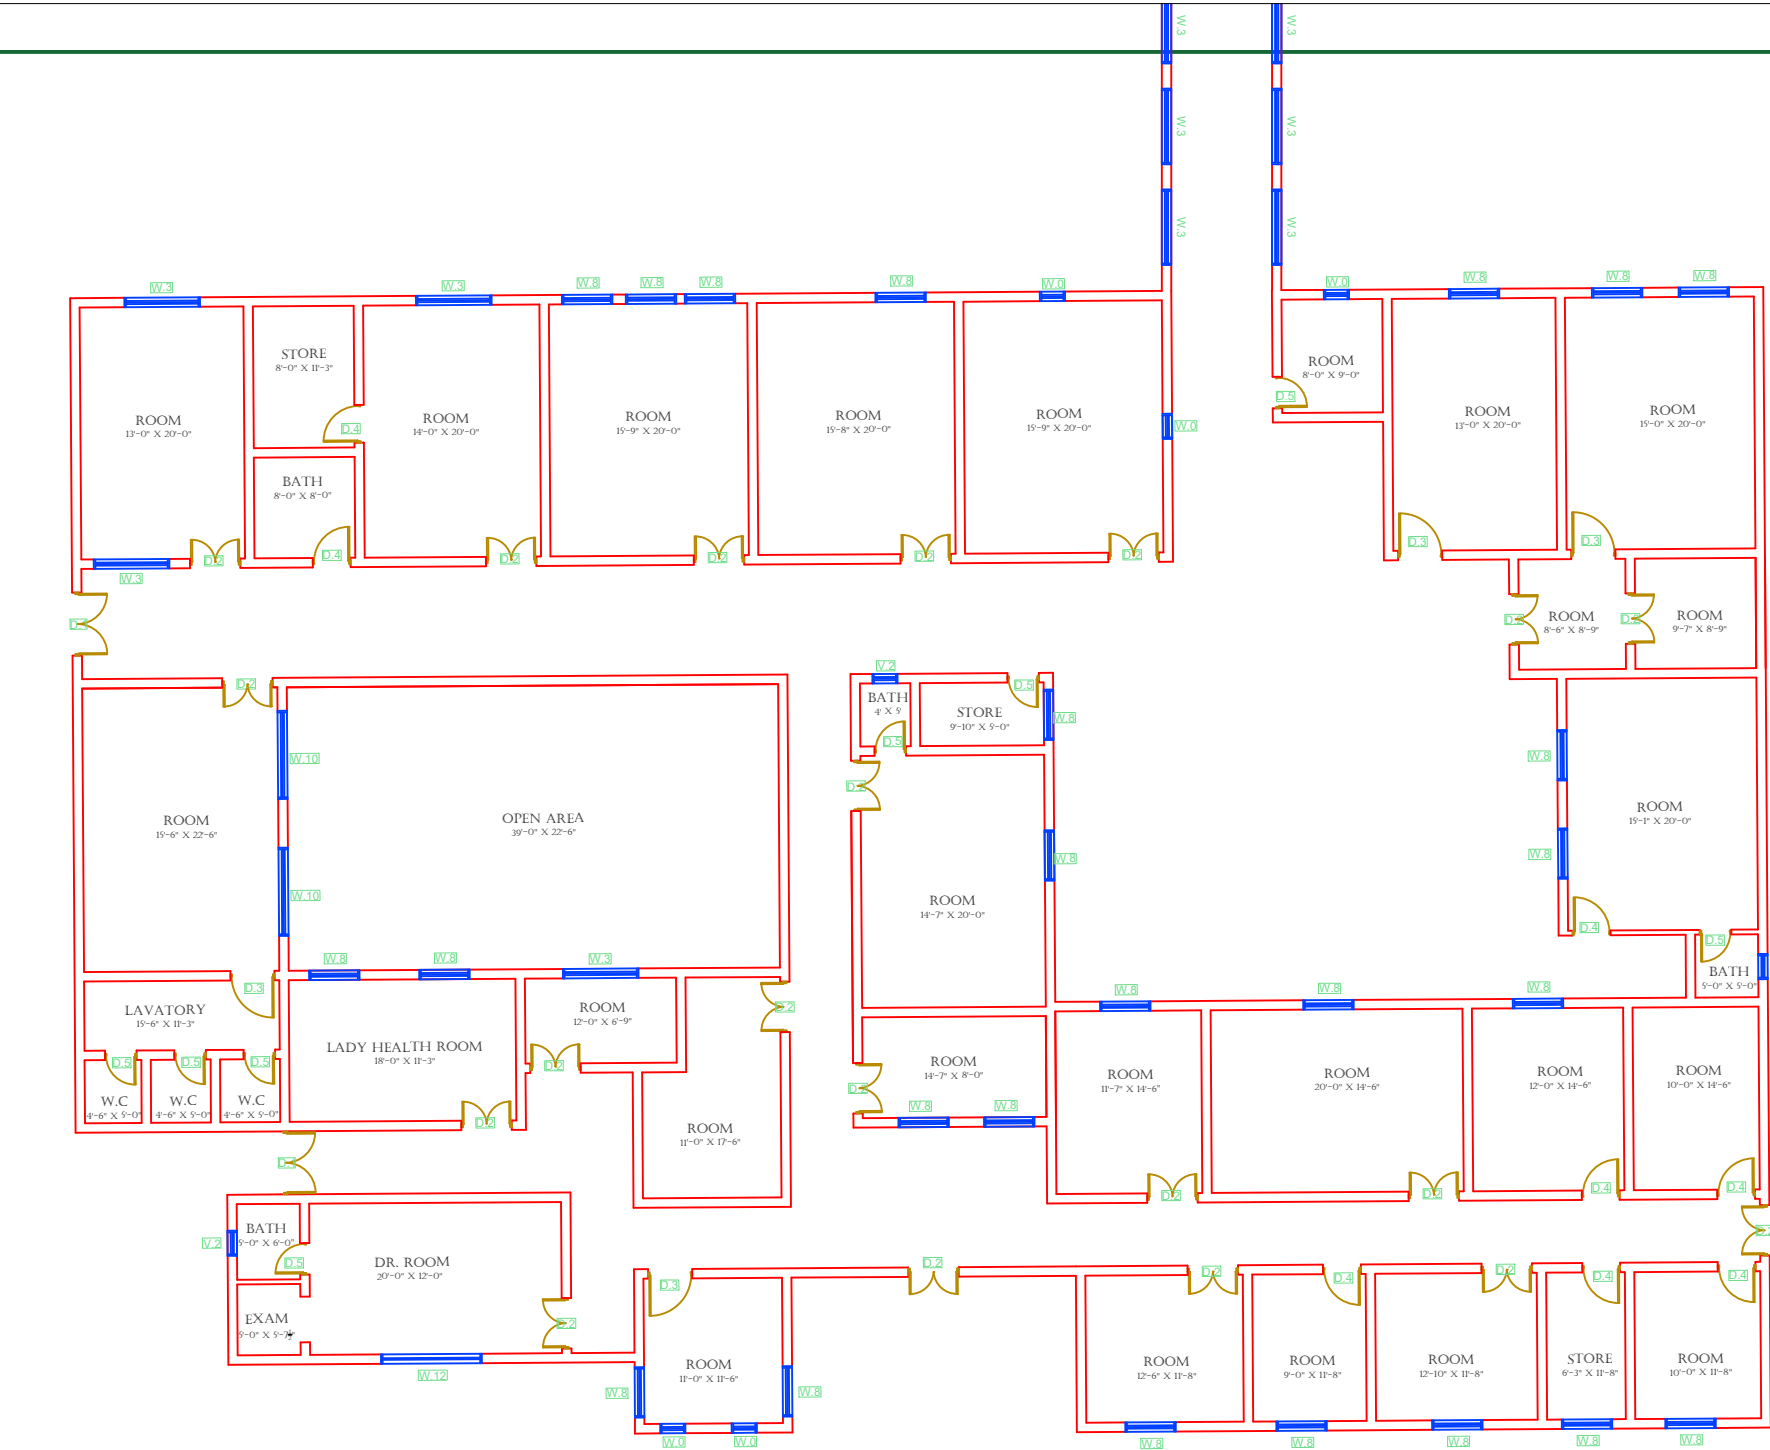

EMERGENCY BLOCK

Legends:

RESIDENTIAL AREA	
ROAD	
WALL	
POWER LINE	
OHT	
TREE	
MAN HOLE	
TUBE WELL	
LIGHT POLE	
LAWNS	
EARTHEN AREAS	
ASPHALT'S ROADS	
TOUGH PAVERS	
P.C.C / PLINTH	
BOUNDARY WALL	
BRICK PAVERS / SOLING	
DRAIN	
TAP	
HAND PUMP	
AIR CONDITIONER	
TUBE LIGHT	
FAN	
ROOF LIGHT	
BULB	

AREA	
AREA WITHIN BOUNDARY WALL	257503.46 SFT
AREA OF CLINICAL BLOCK	25776.25 SFT
PLINTH AREA OF BLOCK	17919.65 SFT

OPENING SCHEDULE OF DOORS AND WINDOWS					
DOORS	WIDTH	HEIGHT	WINDOWS	WIDTH	HEIGHT
D1	5'-6"	7'-0"	W1	3'-0"	3'-0"
D2	5'-0"	7'-0"	W2	3'-6"	3'-6"
D3	4'-0"	7'-0"	W3	6'-0"	6'-0"
D4	3'-6"	7'-0"	W4	4'-6"	4'-6"
D5	3'-0"	7'-0"	W5	8'-6"	8'-6"
D6	2'-6"	7'-0"	W7	2'-6"	2'-6"
D7	6'-0"	7'-0"	W8	4'-0"	4'-0"
V1	1'-6"	1'-6"	W9	5'-0"	5'-0"
V2	2'-0"	2'-0"	W10	7'-0"	7'-0"

Project:
CAD MAPPING OF TEHSIL HEAD QUARTER HOSPITALS, PUNJAB


Client: GOVERNMENT OF THE PUNJAB PRIMARY & SECONDARY HEALTHCARE DEPARTMENT	Consultant: SKAFS CONSULTANT (Pvt.) Limited ENGINEERING AND ENVIRONMENT CONSULTANT
---	--

Drawing Title:
THQ KALLAR SYEDAN CLINICAL BLOCK PLAN (PART 3)

Drawing No.
SKAFS/KALLAR.SYD/11

CLINICAL BLOCK OF THQ HOSPITAL KALLAR SYEDAN

FIRST FLOOR PART 1

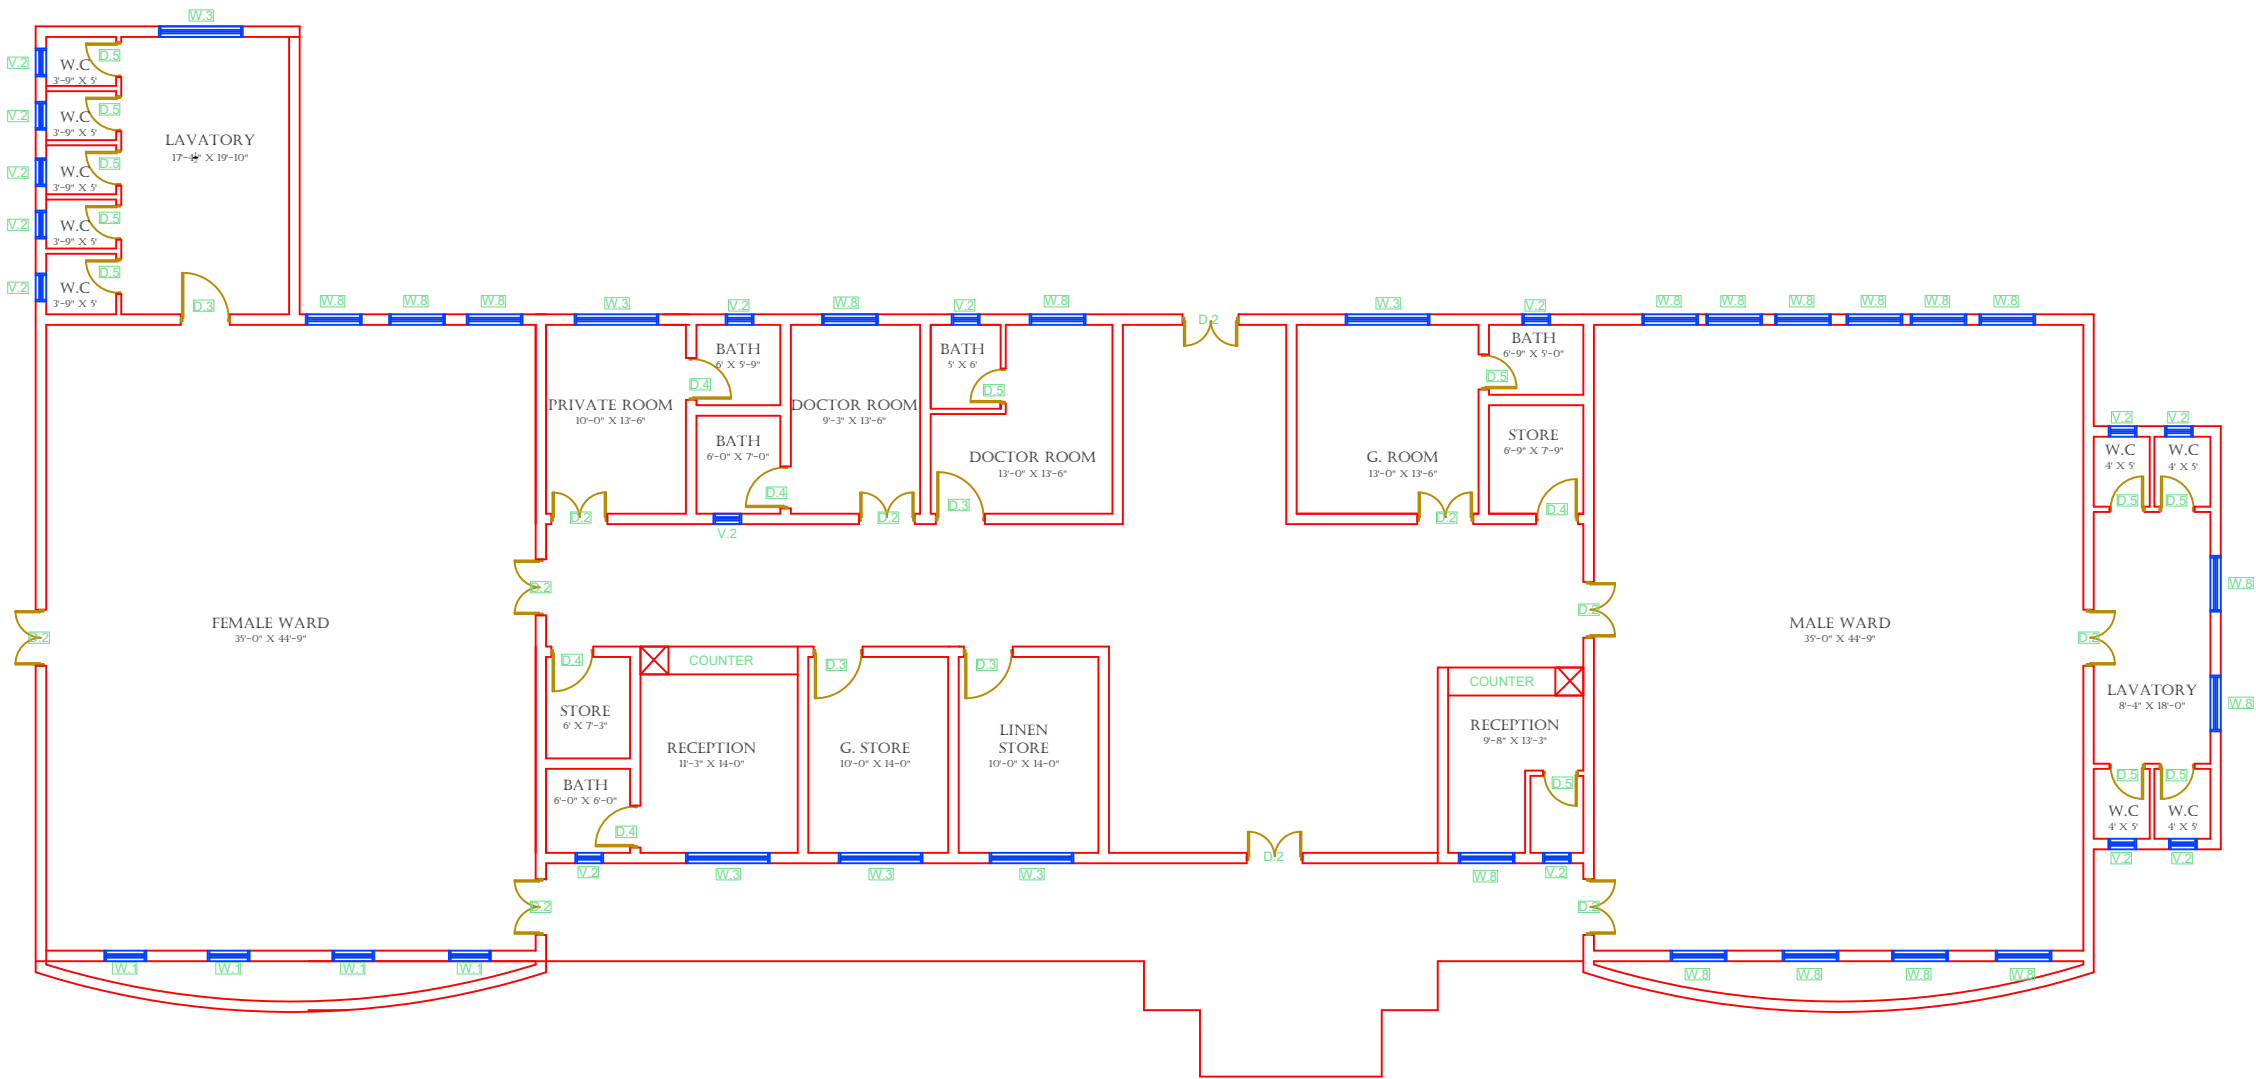

FIRST FLOOR O.P.D BLOCK

Legends:

RESIDENTIAL AREA	
ROAD	
WALL	
POWER LINE	
OHT	
TREE	
MAN HOLE	
TUBE WELL	
LIGHT POLE	
LAWNS	
EARTHEN AREAS	
ASPHALT'S ROADS	
TOUGH PAVERS	
P.C.C / PLINTH	
BOUNDARY WALL	
BRICK PAVERS / SOLING	
DRAIN	
TAP	
HAND PUMP	
AIR CONDITIONER	
TUBE LIGHT	
FAN	
ROOF LIGHT	
BULB	

AREA	
AREA WITHIN BOUNDARY WALL	257503.46 SFT
AREA OF CLINICAL BLOCK	25776.25 SFT
PLINTH AREA OF BLOCK	17919.65 SFT

OPENING SCHEDULE OF DOORS AND WINDOWS					
DOORS	WIDTH	HEIGHT	WINDOWS	WIDTH	HEIGHT
D1	5'-6"	7'-0"	W1	3'-0"	3'-0"
D2	5'-0"	7'-0"	W2	3'-6"	3'-6"
D3	4'-0"	7'-0"	W3	6'-0"	6'-0"
D4	3'-6"	7'-0"	W4	4'-6"	4'-6"
D5	3'-0"	7'-0"	W5	8'-6"	8'-6"
D6	2'-6"	7'-0"	W7	2'-6"	2'-6"
D7	6'-0"	7'-0"	W8	4'-0"	4'-0"
V1	1'-6"	1'-6"	W9	5'-0"	5'-0"
V2	2'-0"	2'-0"	W10	7'-0"	7'-0"

Project:
CAD MAPPING OF TEHSIL HEAD QUARTER HOSPITALS, PUNJAB


Client: GOVERNMENT OF THE PUNJAB PRIMARY & SECONDARY HEALTHCARE DEPARTMENT	Consultant: SKAFS CONSULTANT (Pvt.) Limited ENGINEERING AND ENVIRONMENT CONSULTANT
---	--

Drawing Title:
THQ KALLAR SYEDAN FIRST FLOOR PLAN (PART 1)

Drawing No.
SKAFS/KALLAR.SYD/12

ELECTRICAL LAYOUT PLAN OF THQ HOSPITAL KALLAR SYEDAN

GROUND FLOOR

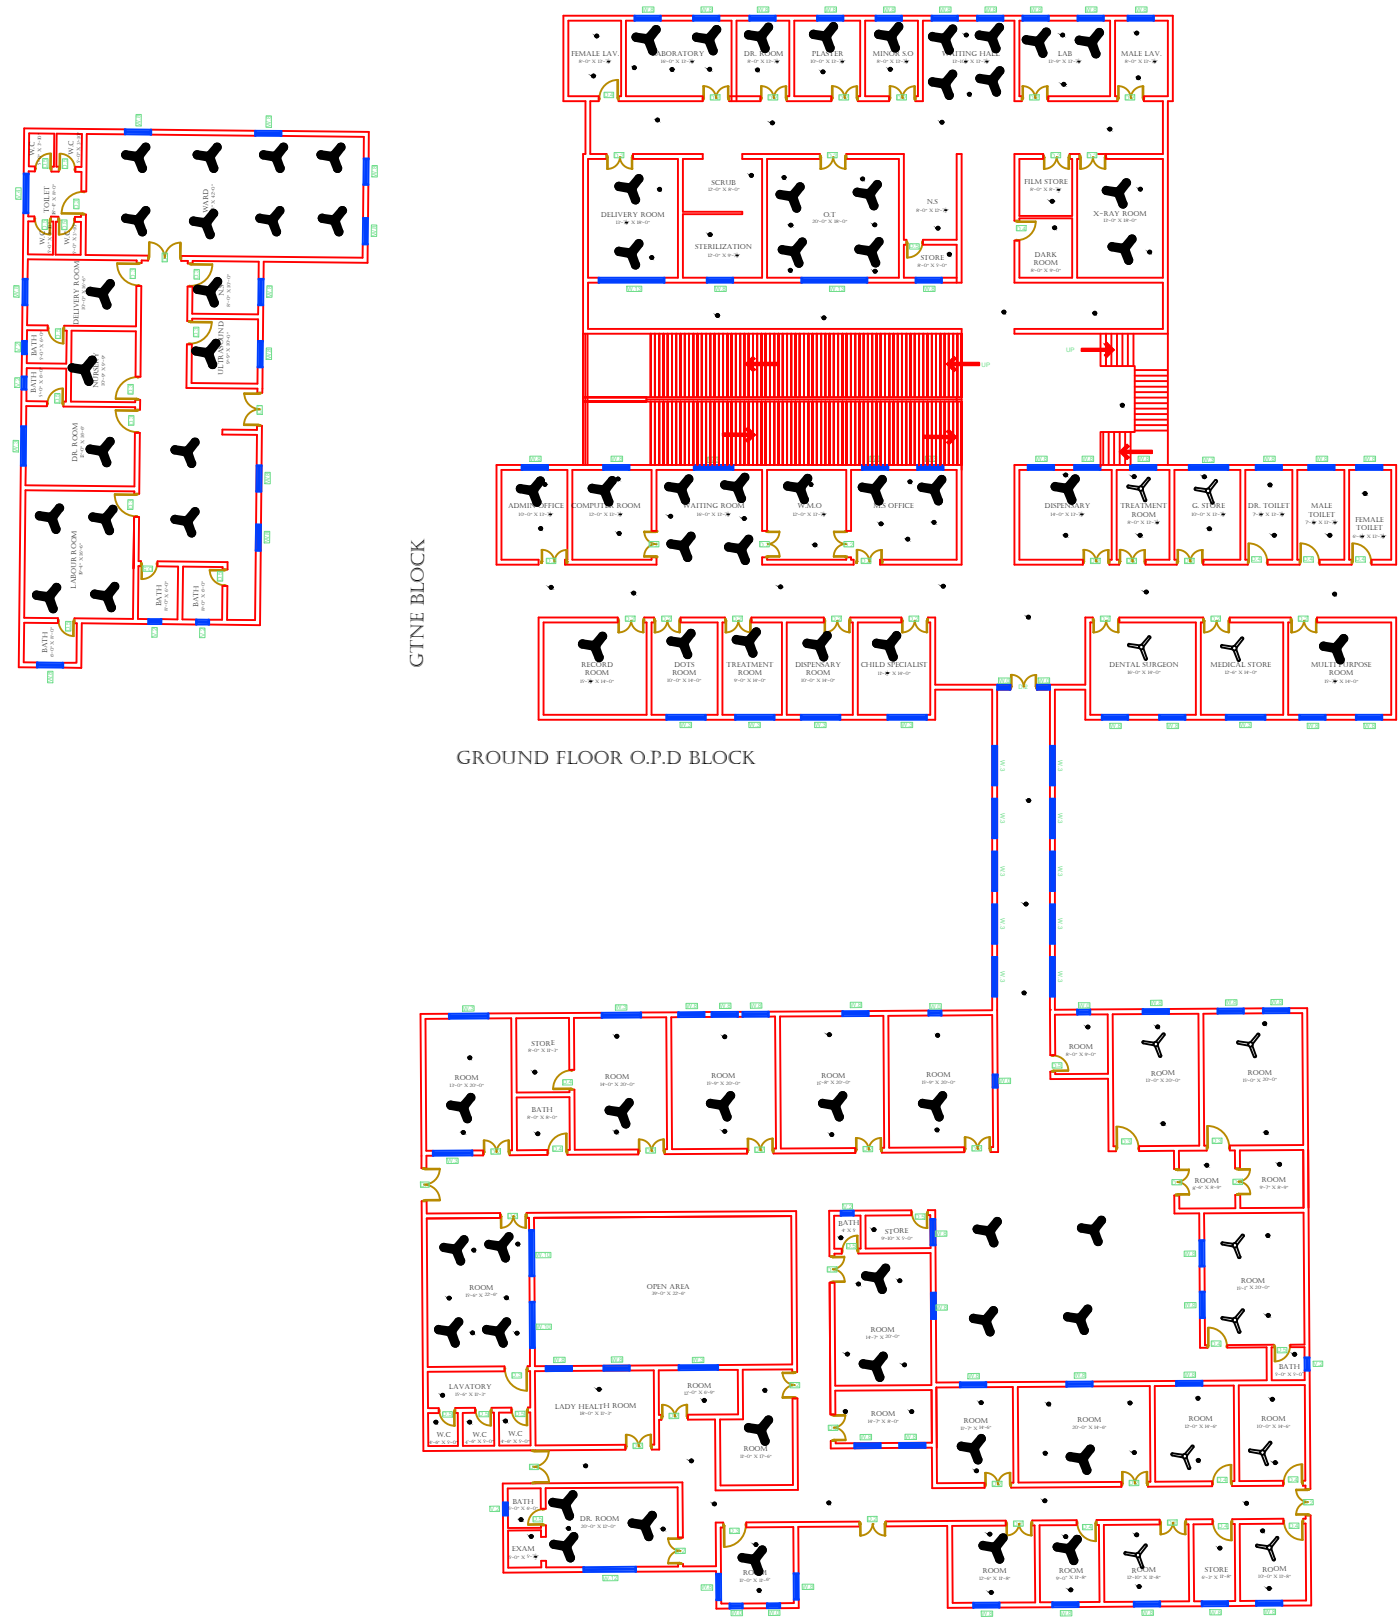

Legends:

RESIDENTIAL AREA	
ROAD	
WALL	
POWER LINE	
OHT	
TREE	
MAN HOLE	
TUBE WELL	
LIGHT POLE	
LAWNS	
EARTHEN AREAS	
ASPHALTS ROADS	
TOUGH PAVERS	
P.C.C / PLINTH	
BOUNDARY WALL	
BRICK PAVERS / SOLING	
DRAIN	
TAP	
HAND PUMP	
AIR CONDITIONER	
TUBE LIGHT	
FAN	
ROOF LIGHT	
BULB	

AREA

AREA WITHIN BOUNDARY WALL	257503.46 SFT
AREA OF CLINICAL BLOCK	25776.25 SFT
PLINTH AREA OF BLOCK	17919.65 SFT

OPENING SCHEDULE OF DOORS AND WINDOWS

DOORS	WIDTH	HEIGHT	WINDOWS	WIDTH	HEIGHT
D1	5'-6"	7'-0"	W1	3'-0"	3'-0"
D2	5'-0"	7'-0"	W2	3'-6"	3'-6"
D3	4'-0"	7'-0"	W3	6'-0"	6'-0"
D4	3'-6"	7'-0"	W4	4'-6"	4'-6"
D5	3'-0"	7'-0"	W5	8'-6"	8'-6"
D6	2'-6"	7'-0"	W7	2'-6"	2'-6"
D7	6'-0"	7'-0"	W8	4'-0"	4'-0"
V1	1'-6"	1'-6"	W9	5'-0"	5'-0"
V2	2'-0"	2'-0"	W10	7'-0"	7'-0"

Project:
CAD MAPPING OF TEHSIL HEAD QUARTER HOSPITALS, PUNJAB


Client: GOVERNMENT OF THE PUNJAB PRIMARY & SECONDARY HEALTHCARE DEPARTMENT	Consultant: SKAFS CONSULTANT (Pvt.) Limited ENGINEERING AND ENVIRONMENT CONSULTANT
---	--

Drawing Title:
**THQ KALLAR SYEDAN
ELECTRICAL PLAN (GROUND FLOOR)**

Drawing No.
SKAFS/KALLAR.SYD/13

ELECTRICAL LAYOUT PLAN OF THQ HOSPITAL KALLAR SYEDAN

FIRST FLOOR

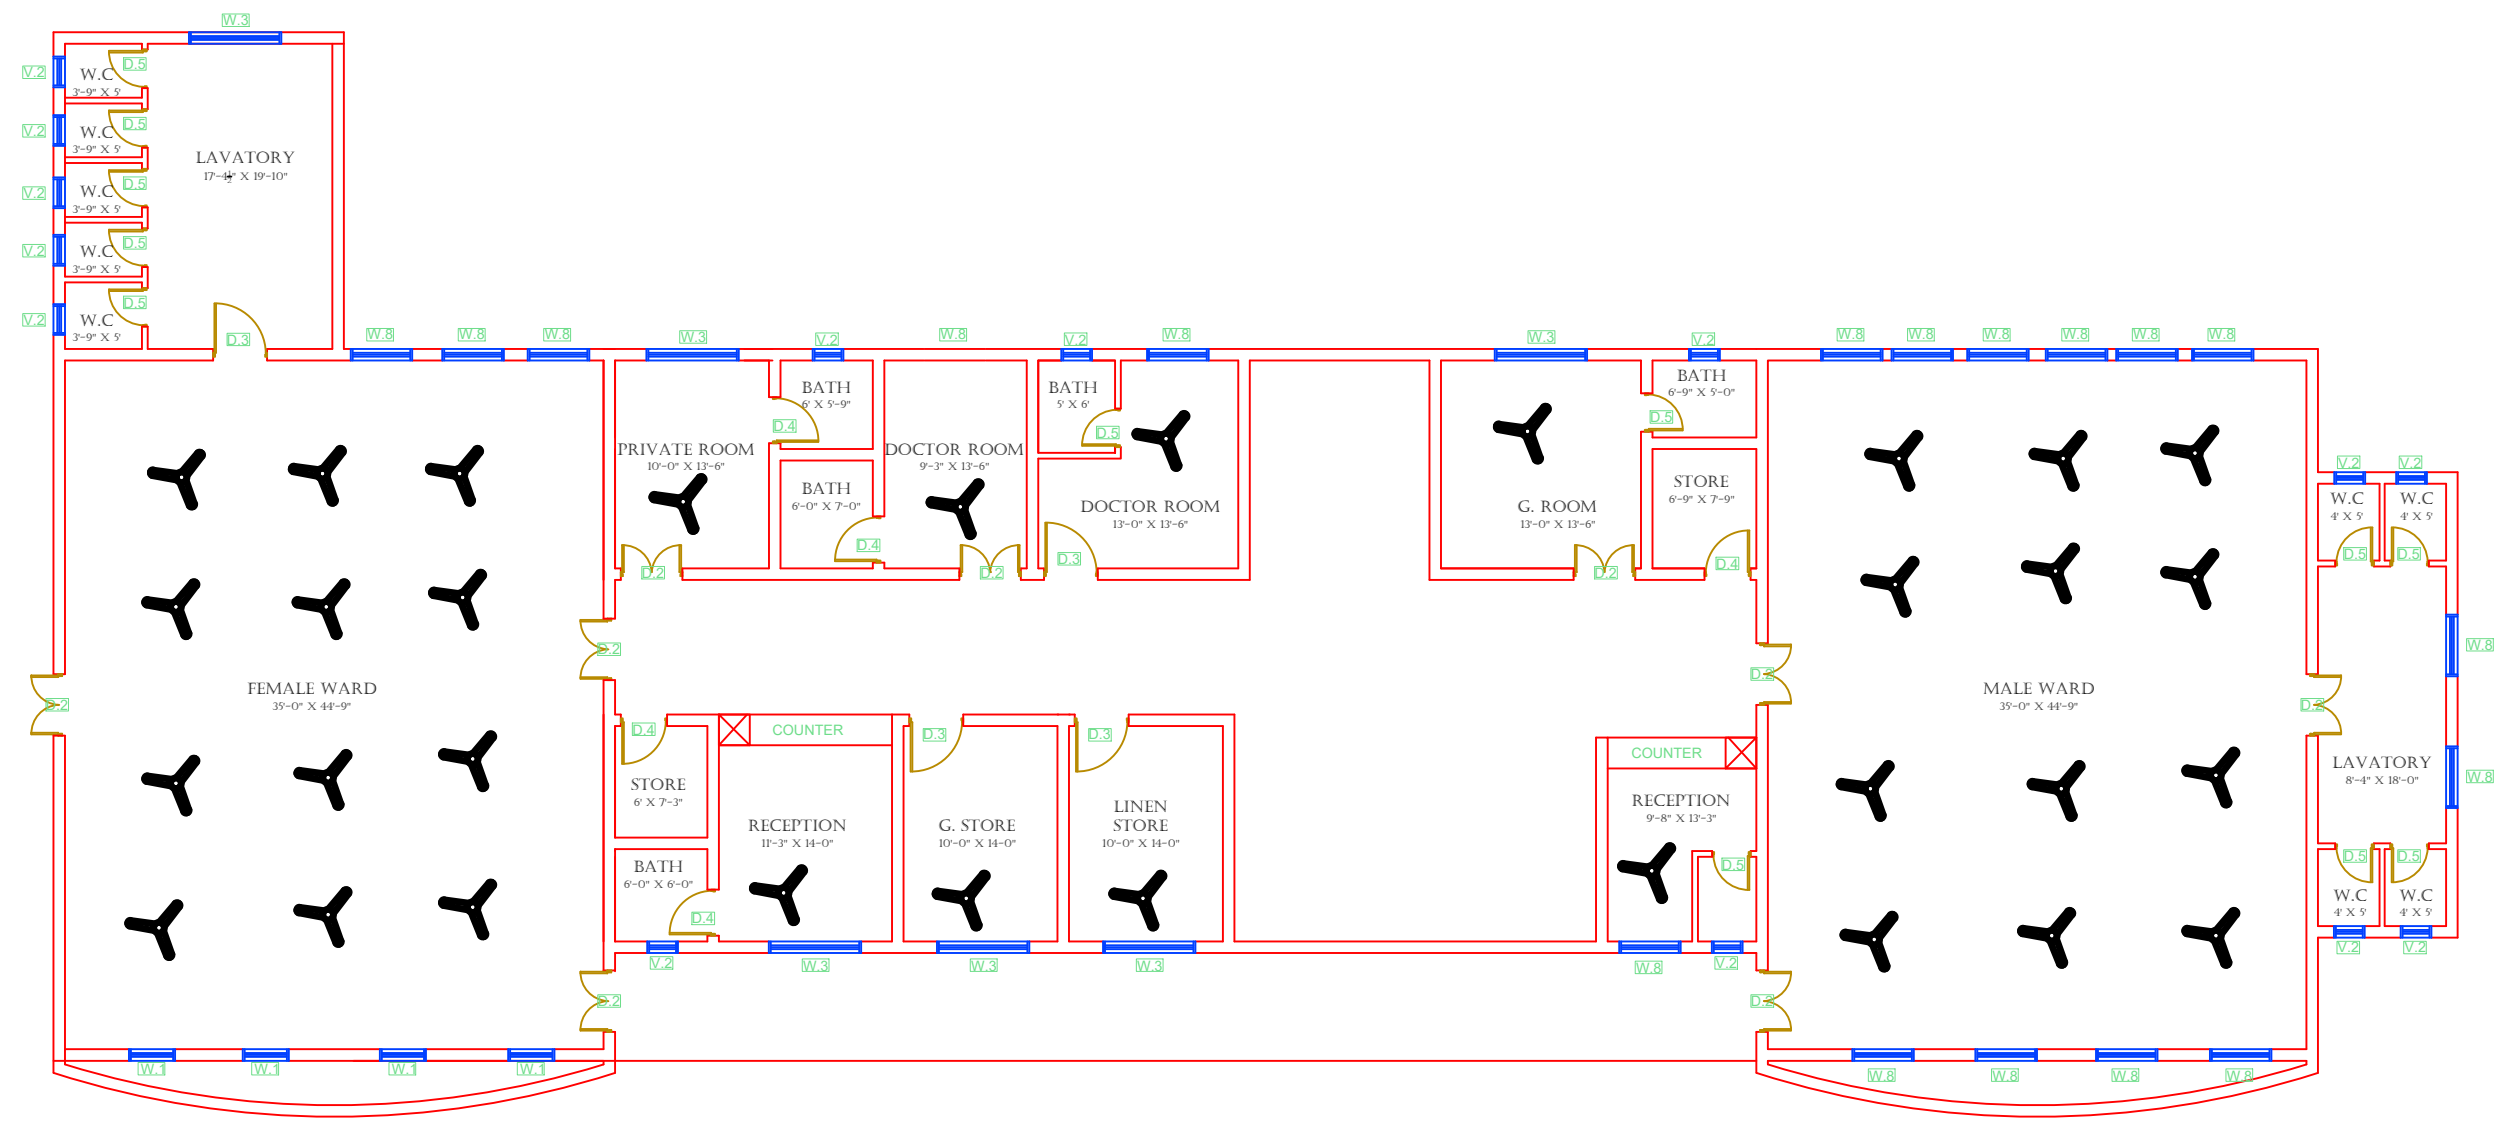

FIRST FLOOR O.P.D BLOCK

Legends:

RESIDENTIAL AREA	
ROAD	
WALL	
POWER LINE	
OHT	
TREE	
MAN HOLE	
TUBE WELL	
LIGHT POLE	
LAWNS	
EARTHEN AREAS	
ASPHALTS ROADS	
TOUGH PAVERS	
P.C.C / PLINTH	
BOUNDARY WALL	
BRICK PAVERS / SOLING	
DRAIN	
TAP	
HAND PUMP	
AIR CONDITIONER	
TUBE LIGHT	
FAN	
ROOF LIGHT	
BULB	

AREA	
AREA WITHIN BOUNDARY WALL	257503.46 SFT
AREA OF CLINICAL BLOCK	25776.25 SFT
PLINTH AREA OF BLOCK	17919.65 SFT

OPENING SCHEDULE OF DOORS AND WINDOWS					
DOORS	WIDTH	HEIGHT	WINDOWS	WIDTH	HEIGHT
D1	5'-6"	7'-0"	W1	3'-0"	3'-0"
D2	5'-0"	7'-0"	W2	3'-6"	3'-6"
D3	4'-0"	7'-0"	W3	6'-0"	6'-0"
D4	3'-6"	7'-0"	W4	4'-6"	4'-6"
D5	3'-0"	7'-0"	W5	8'-6"	8'-6"
D6	2'-6"	7'-0"	W7	2'-6"	2'-6"
D7	6'-0"	7'-0"	W8	4'-0"	4'-0"
V1	1'-6"	1'-6"	W9	5'-0"	5'-0"
V2	2'-0"	2'-0"	W10	7'-0"	7'-0"

Project: **CAD MAPPING OF TEHSIL HEAD QUARTER HOSPITALS, PUNJAB**

Client: GOVERNMENT OF THE PUNJAB PRIMARY & SECONDARY HEALTHCARE DEPARTMENT	Consultant: SKAFS CONSULTANT (Pvt.) Limited ENGINEERING AND ENVIRONMENT CONSULTANT
---	--

Drawing Title: **THQ KALLAR SYEDAN ELECTRICAL PLAN (FIRST FLOOR)**

Drawing No. **SKAFS/KALLAR.SYD/14**