


MASTER PLAN OF THQ HOSPITAL KALLUR KOT

PART 1

PART 2

PART 3

PART 4

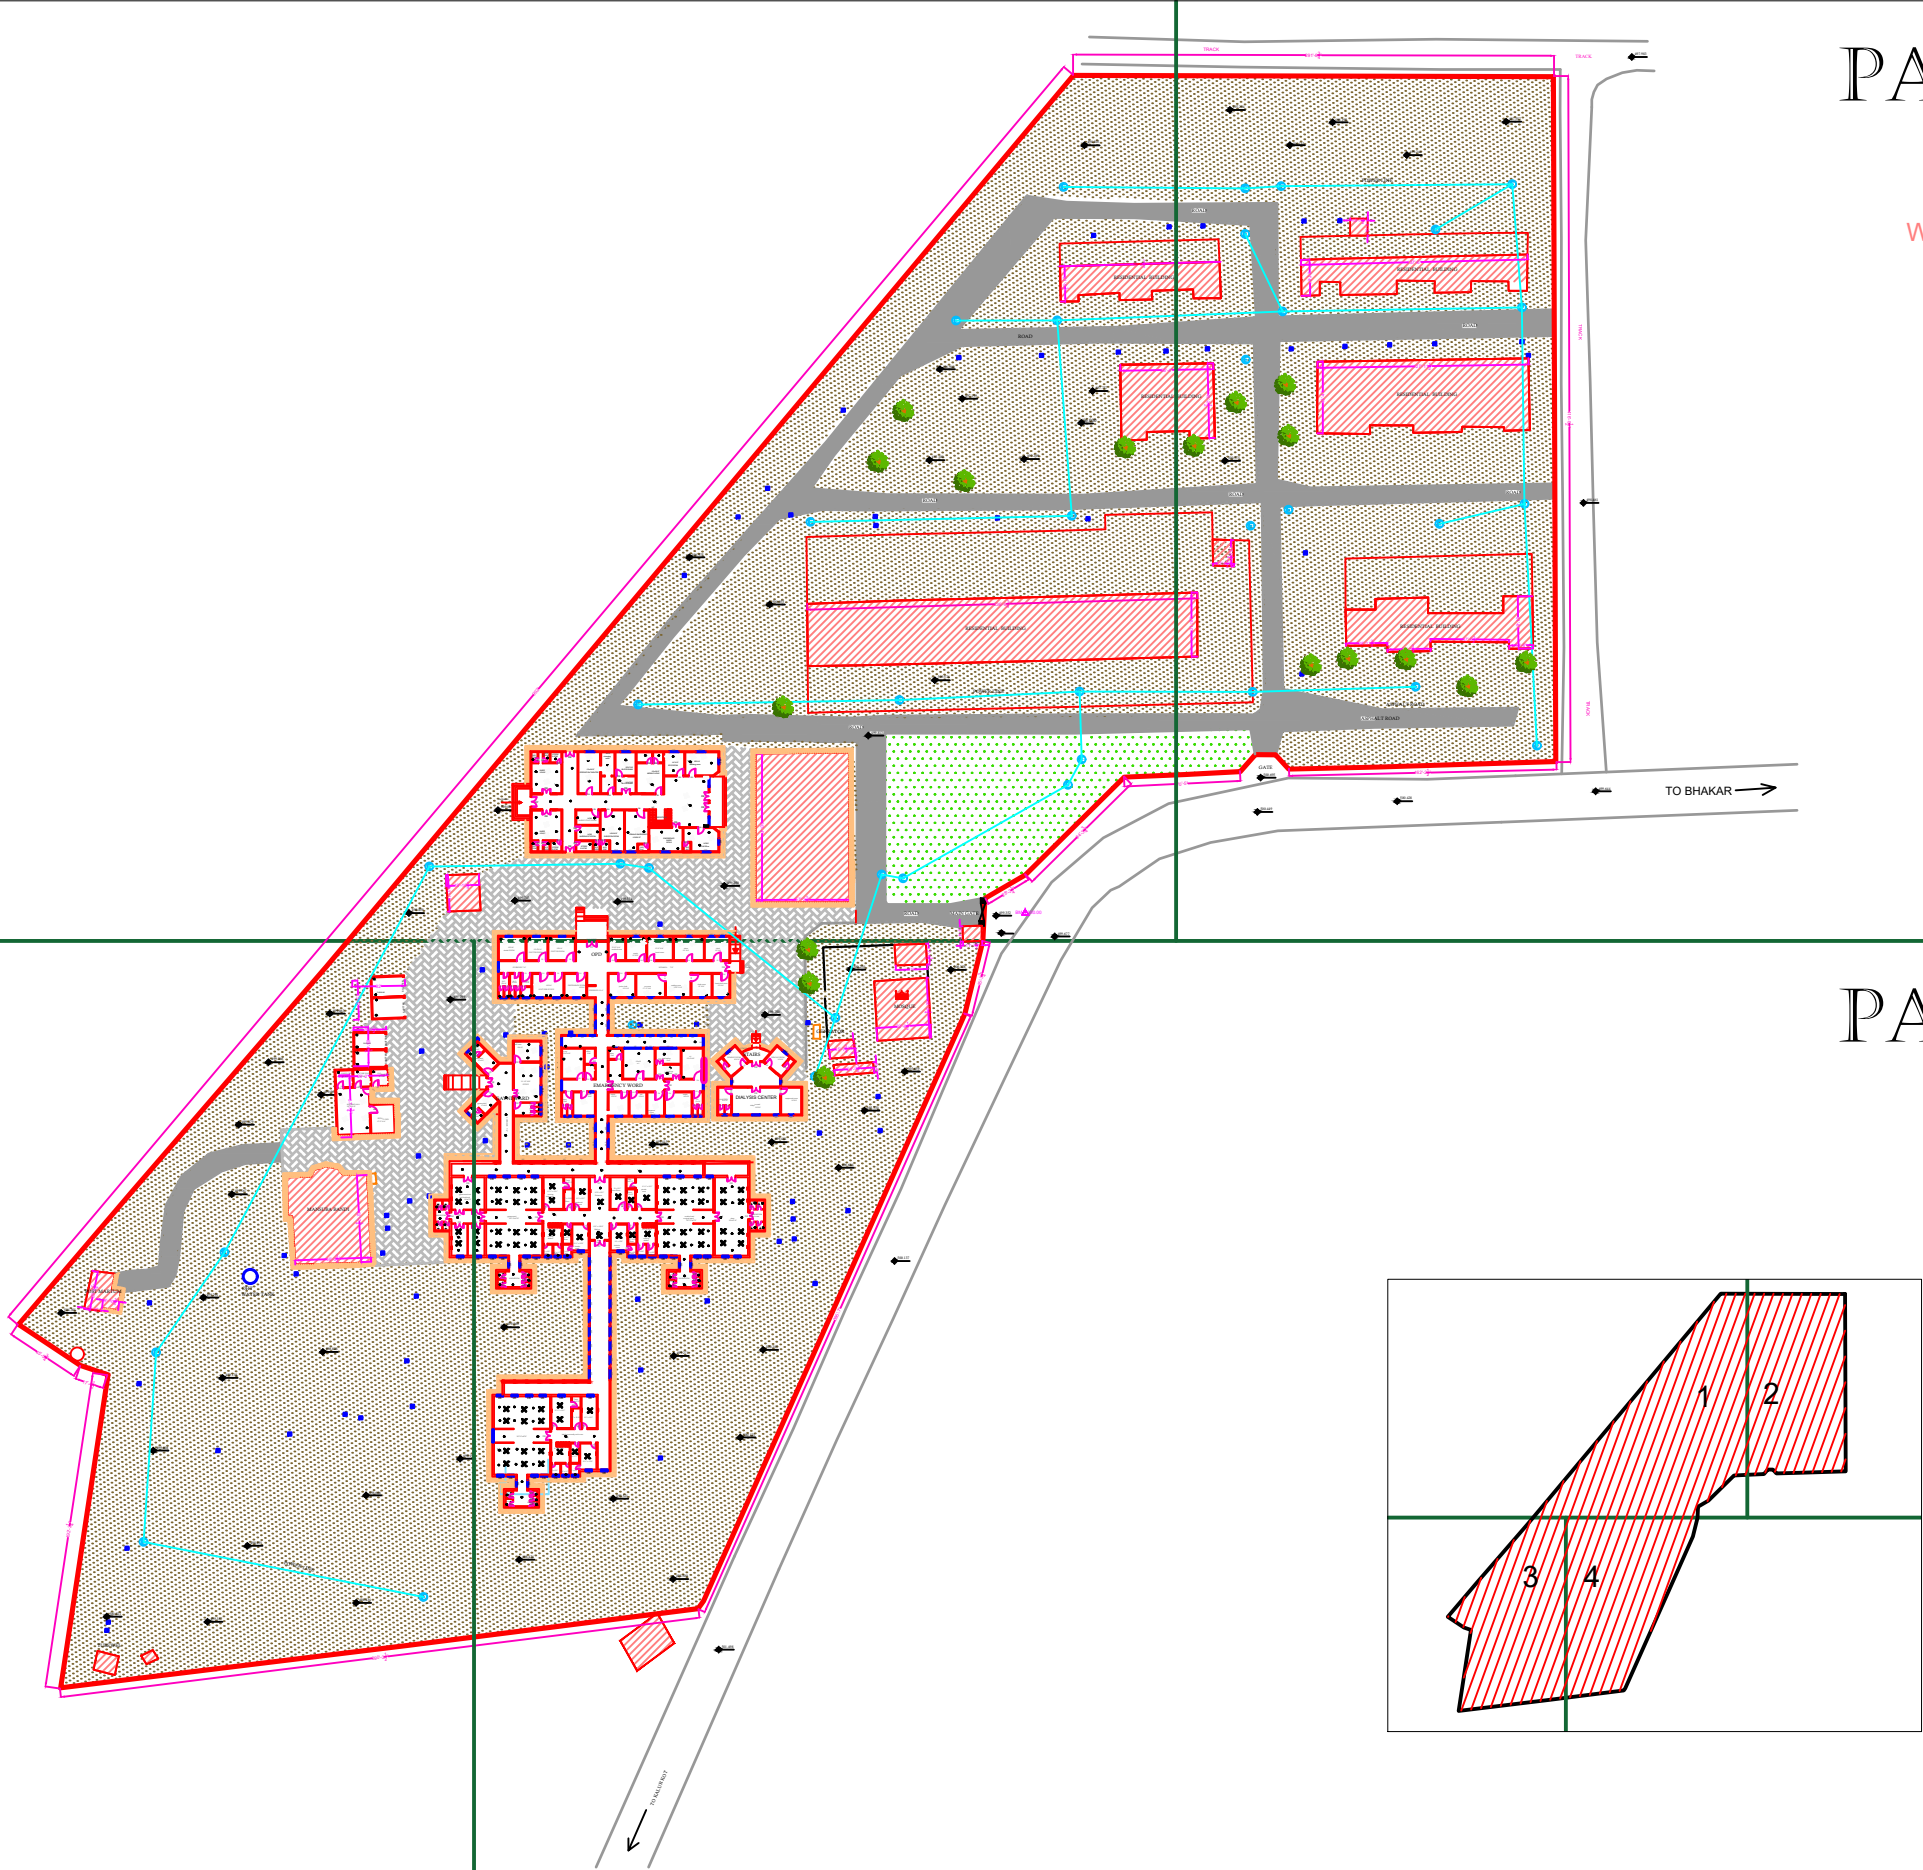

Legends:	
Residential Area	
Road	
Wall	
Power Line	
OHT	
Tree	
Man Hole	
Tube Well	
Light Pole	
Lawns	
Earthen Areas	
Asphalts Roads	
Tough Pavers	
P.C.C / Plinth Protection	
Boundary Wall	
Brick Pavers / Soling	
Drain	
Tap	
Hand Pump	
Air Conditioner	
Tube Light	
Fan	
Roof Light	
Bulb	

AREA	
AREA WITHIN BOUNDARY WALL	420042.65 Sft
AREA OF CLINICAL BLOCK	38054.4 Sft
PLINTH AREA OF BLOCK	38054.4 Sft

OPENING SCHEDULE OF DOORS AND WINDOWS					
DOORS	WIDTH	HEIGHT	WINDOWS	WIDTH	HEIGHT
D1	2'-0"	7'-0"	W1	3'-0"	2'-6"
D2	3'-6"	7'-0"	W2	4'-0"	3'-0"
D3	3'-0"	7'-0"	W3	6'-0"	4'-0"
D4	4'-0"	7'-0"	W4	8'-0"	5'-0"
D5	4'-6"	7'-0"	W5		
D6	2'-6"	7'-0"	W6		
D7	6'-0"	7'-0"	W7		
D8	5'-0"	7'-0"	V1	2'-0"	2'-0"
D9			V2		

Project:
**CAD MAPPING OF TEHSIL
HEAD QUARTER HOSPITALS,
PUNJAB**



Client: GOVERNMENT OF THE PUNJAB PRIMARY & SECONDARY HEALTHCARE DEPARTMENT	Consultant: SKAFS CONSULTANT (Pvt.) Limited ENGINEERING AND ENVIRONMENT CONSULTANT
---	--

Drawing Title:
**THQ KALLUR KOT
HOSPITAL MASTER PLAN**

Drawing No.
SKAFS/KALLUR KOT/03

MASTER PLAN OF THQ HOSPITAL KALLUR KOT

PART 1

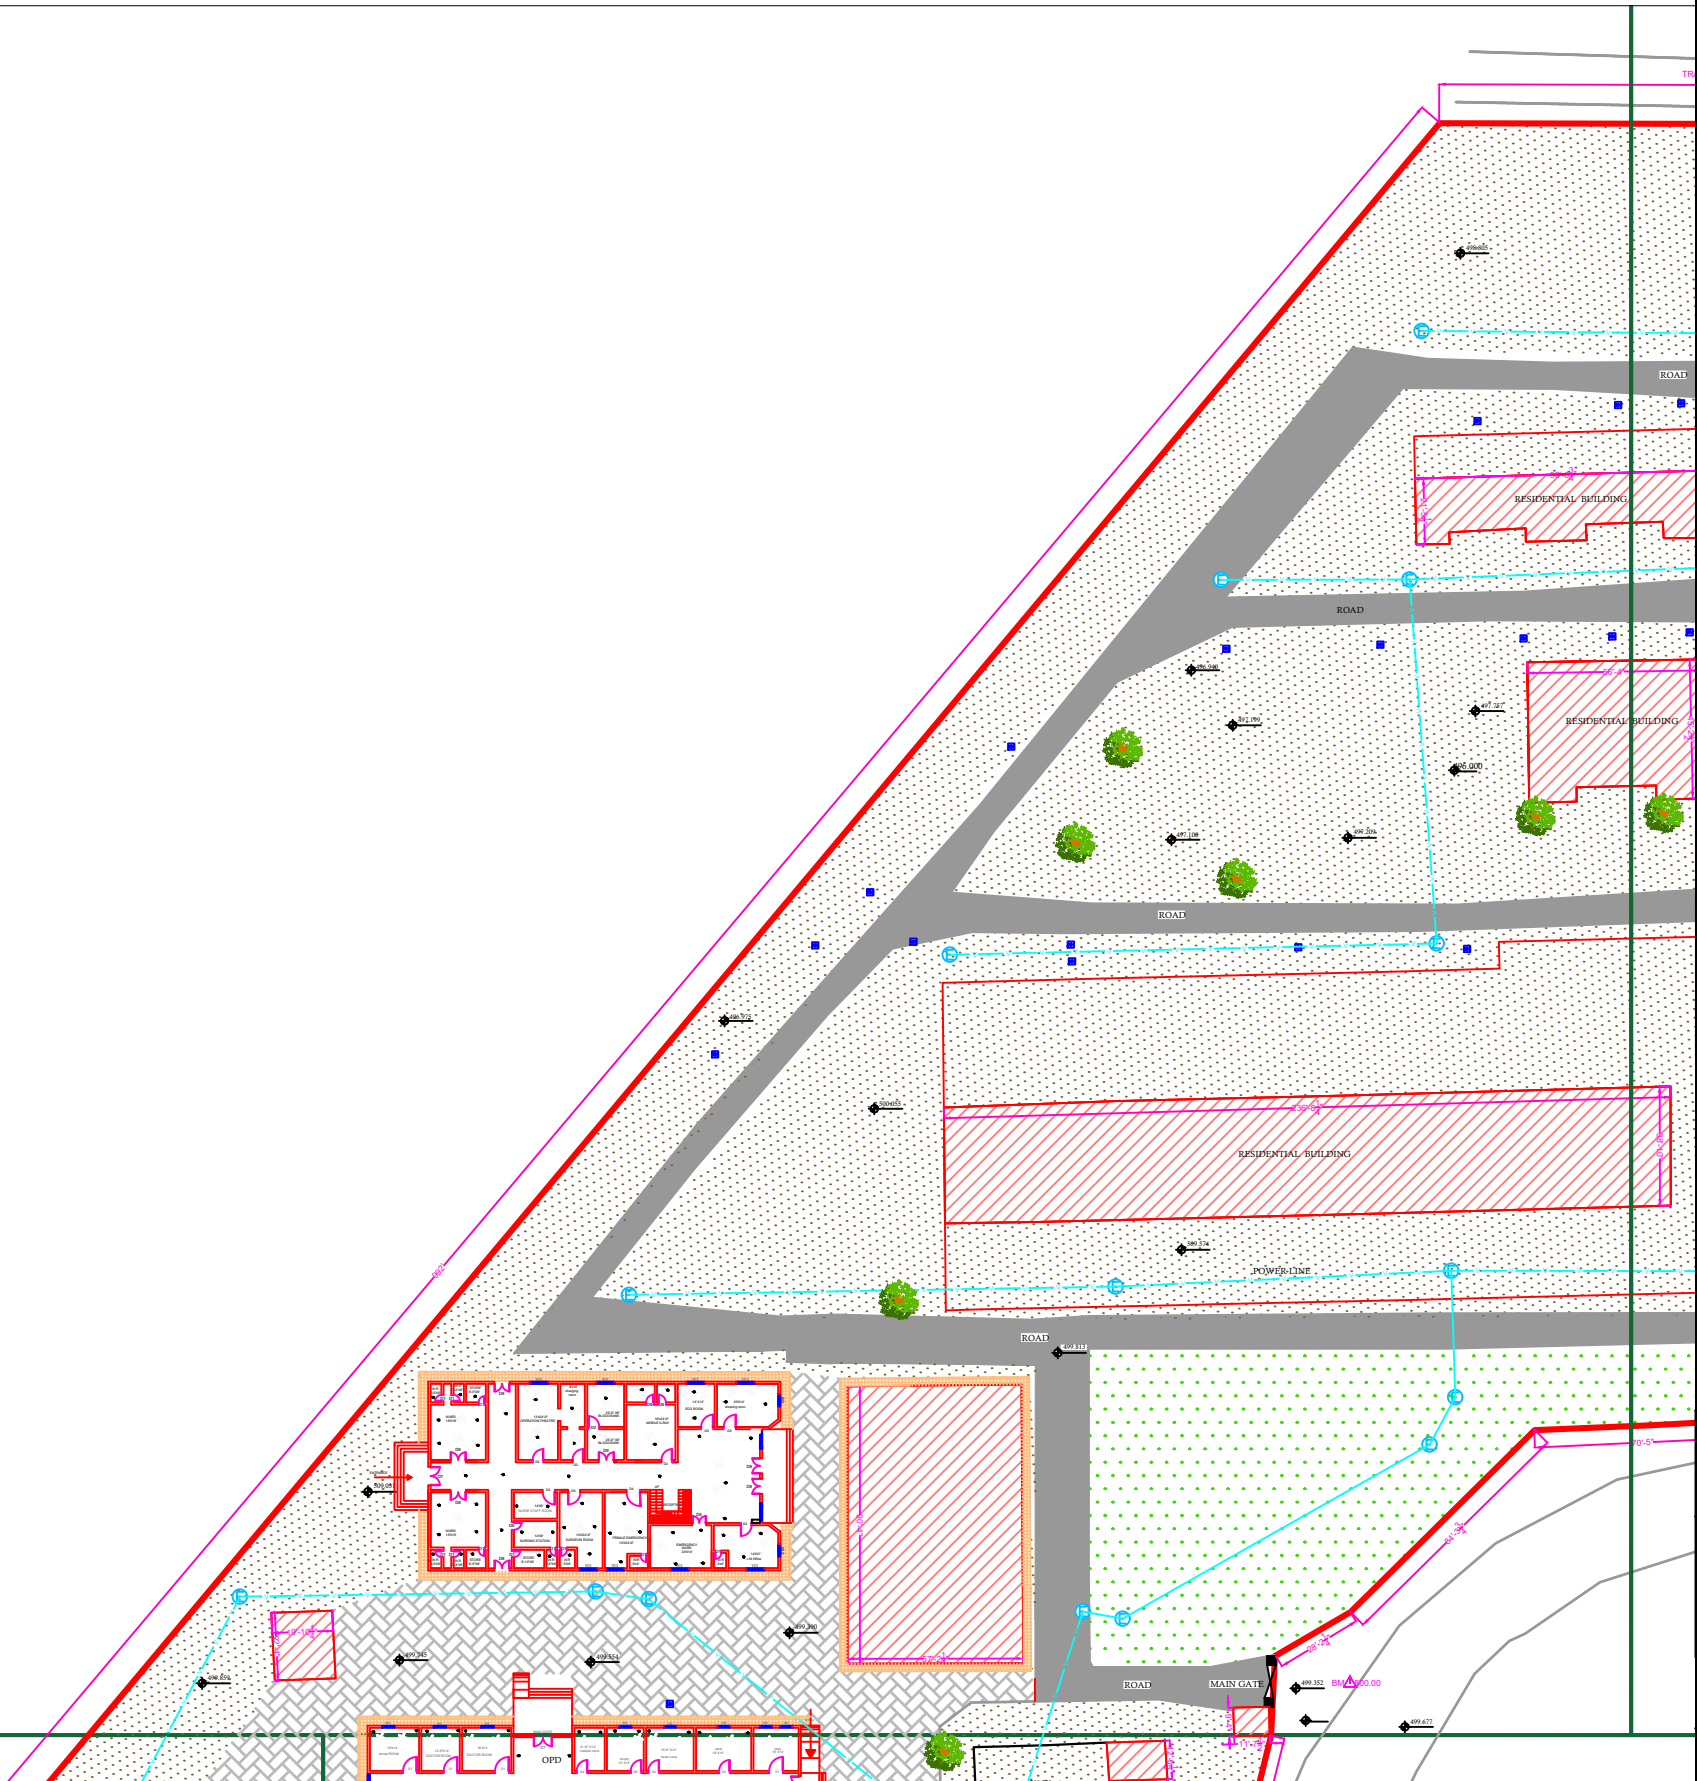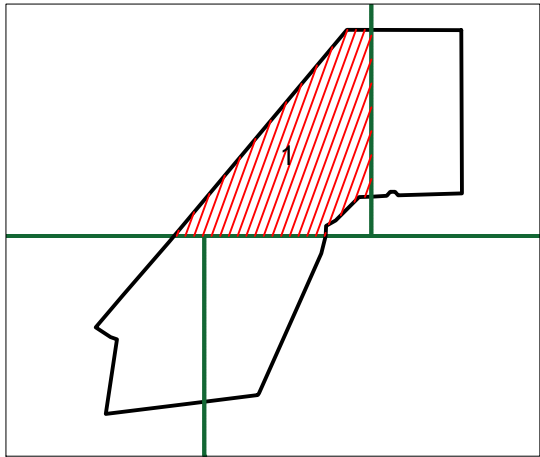

Legends:

Residential Area	
Road	
Wall	
Power Line	
OHT	
Tree	
Man Hole	
Tube Well	
Light Pole	
Lawns	
Earthen Areas	
Asphalts Roads	
Tough Pavers	
P.C.C / Plinth Protection	
Boundary Wall	
Brick Pavers / Soling	
Drain	
Tap	
Hand Pump	
Air Conditioner	
Tube Light	
Fan	
Roof Light	
Bulb	

AREA	
AREA WITHIN BOUNDARY WALL	420042.65 Sft
AREA OF CLINICAL BLOCK	38054.4 Sft
PLINTH AREA OF BLOCK	38054.4 Sft

OPENING SCHEDULE OF DOORS AND WINDOWS					
DOORS	WIDTH	HEIGHT	WINDOWS	WIDTH	HEIGHT
D1	2'-0"	7'-0"	W1	3'-0"	2'-6"
D2	3'-6"	7'-0"	W2	4'-0"	3'-0"
D3	3'-0"	7'-0"	W3	6'-0"	4'-0"
D4	4'-0"	7'-0"	W4	8'-0"	5'-0"
D5	4'-6"	7'-0"	W5		
D6	2'-6"	7'-0"	W6		
D7	6'-0"	7'-0"	W7		
D8	5'-0"	7'-0"	V1	2'-0"	2'-0"
D9			V2		

Project:
**CAD MAPPING OF TEHSIL
HEAD QUARTER HOSPITALS,
PUNJAB**




Client: GOVERNMENT OF THE PUNJAB PRIMARY & SECONDARY HEALTHCARE DEPARTMENT	Consultant: SKAFS CONSULTANT (Pvt.) Limited ENGINEERING AND ENVIRONMENT CONSULTANT
---	--

Drawing Title:
**THQ KALLUR KOT
HOSPITAL MASTER PLAN PART 1**

Drawing No.
SKAFS/KALLUR KOT/04

MASTER PLAN OF THQ HOSPITAL KALLUR KOT

PART 2

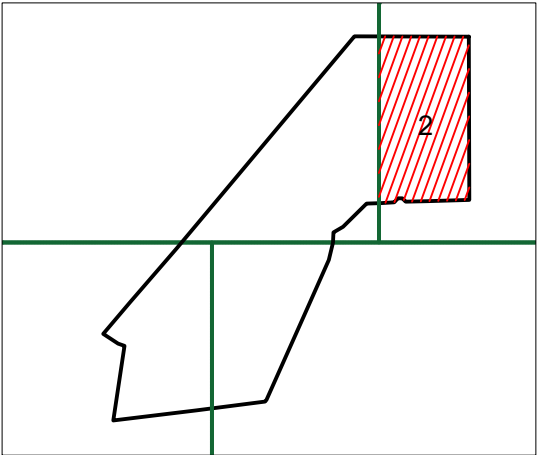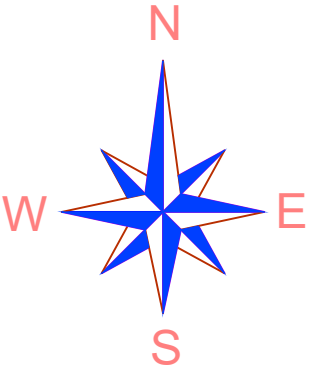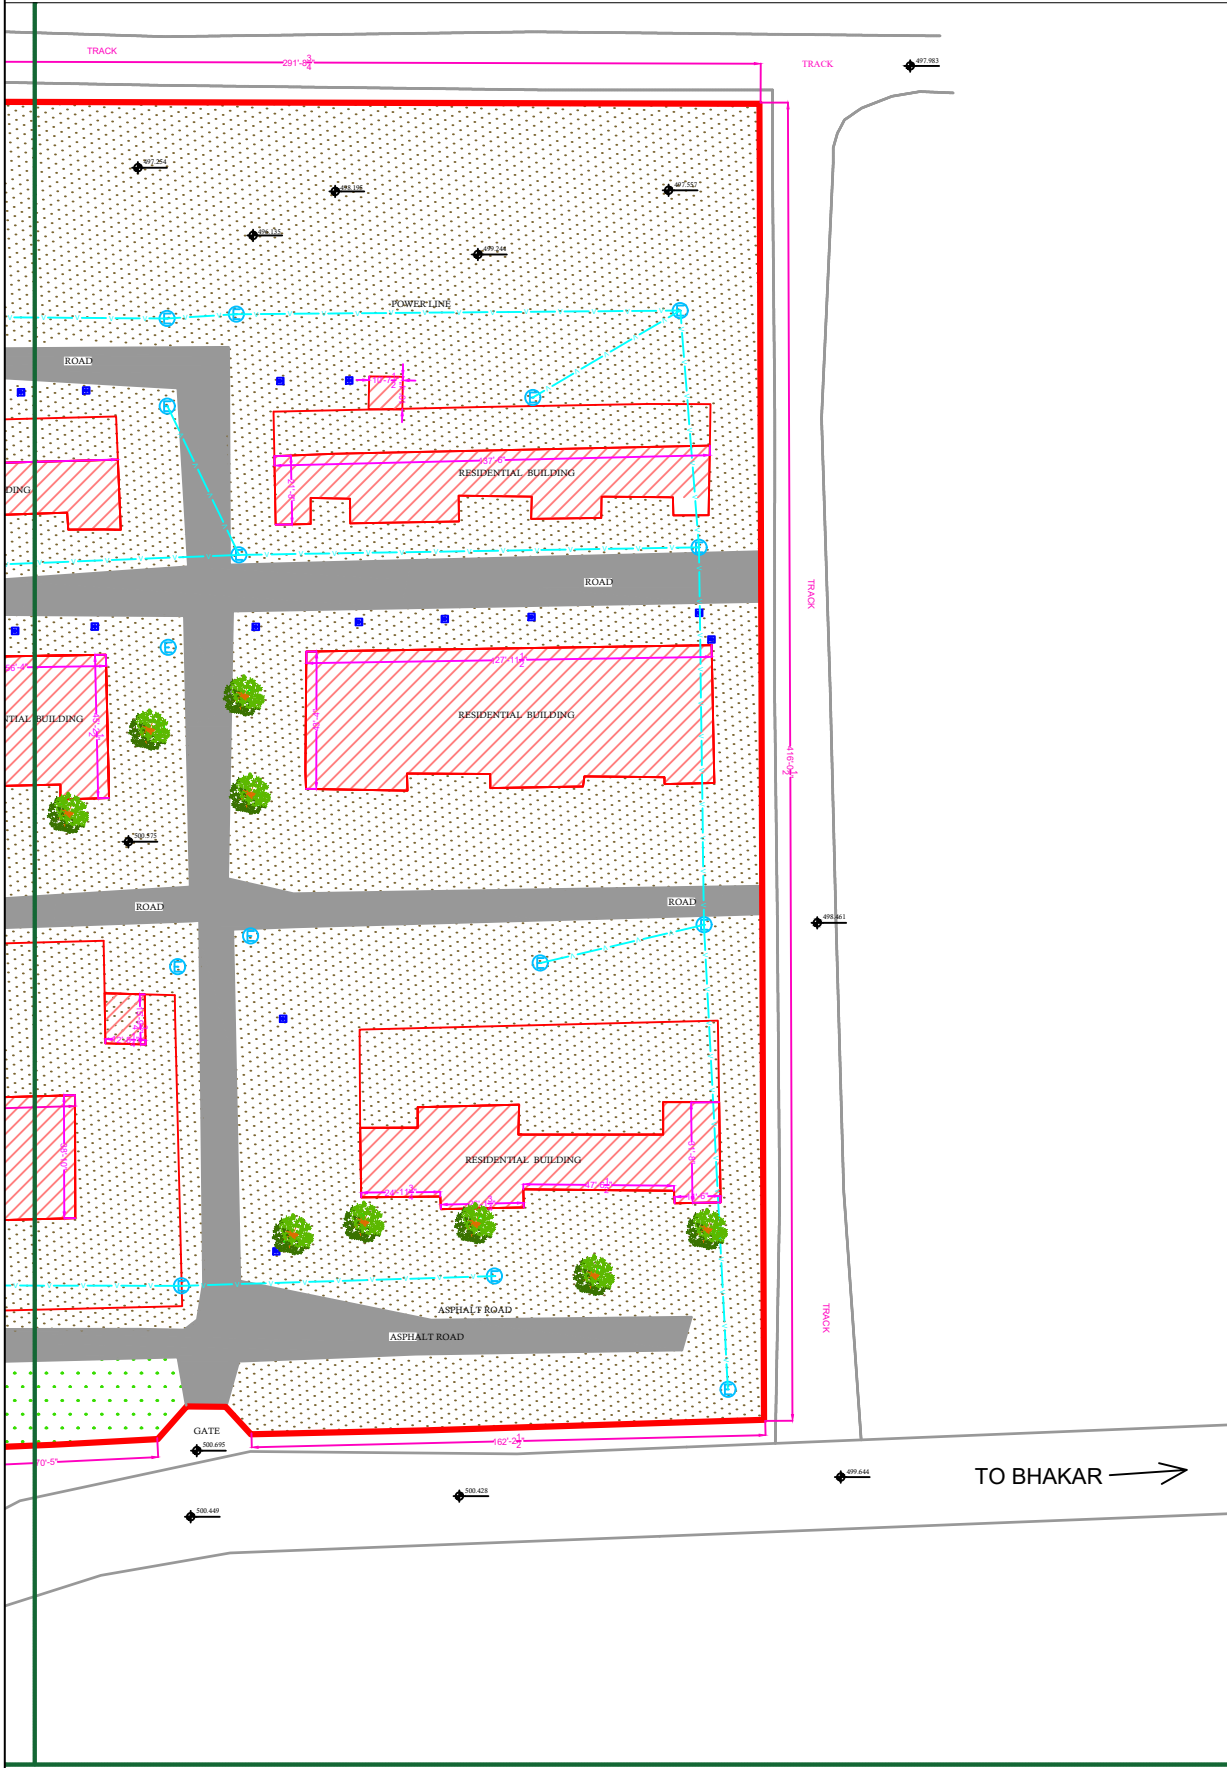

Legends:

Residential Area	
Road	
Wall	
Power Line	
OHT	
Tree	
Man Hole	
Tube Well	
Light Pole	
Lawns	
Earthen Areas	
Asphalts Roads	
Tough Pavers	
P.C.C / Plinth Protection	
Boundary Wall	
Brick Pavers / Soling	
Drain	
Tap	
Hand Pump	
Air Conditioner	
Tube Light	
Fan	
Roof Light	
Bulb	

AREA	
AREA WITHIN BOUNDARY WALL	420042.65 Sft
AREA OF CLINICAL BLOCK	38054.4 Sft
PLINTH AREA OF BLOCK	38054.4 Sft

OPENING SCHEDULE OF DOORS AND WINDOWS					
DOORS	WIDTH	HEIGHT	WINDOWS	WIDTH	HEIGHT
D1	2'-0"	7'-0"	W1	3'-0"	2'-6"
D2	3'-6"	7'-0"	W2	4'-0"	3'-0"
D3	3'-0"	7'-0"	W3	6'-0"	4'-0"
D4	4'-0"	7'-0"	W4	8'-0"	5'-0"
D5	4'-6"	7'-0"	W5		
D6	2'-6"	7'-0"	W6		
D7	6'-0"	7'-0"	W7		
D8	5'-0"	7'-0"	V1	2'-0"	2'-0"
D9			V2		

Project:
**CAD MAPPING OF TEHSIL
HEAD QUARTER HOSPITALS,
PUNJAB**



Client: GOVERNMENT OF THE PUNJAB PRIMARY & SECONDARY HEALTHCARE DEPARTMENT	Consultant: SKAFS CONSULTANT (Pvt.) Limited ENGINEERING AND ENVIRONMENT CONSULTANT
---	--

Drawing Title:
**THQ KALLUR KOT
HOSPITAL MASTER PLAN PART 2**

Drawing No.
SKAFS/KALLUR KOT/05

MASTER PLAN OF THQ HOSPITAL KALLUR KOT

PART 3

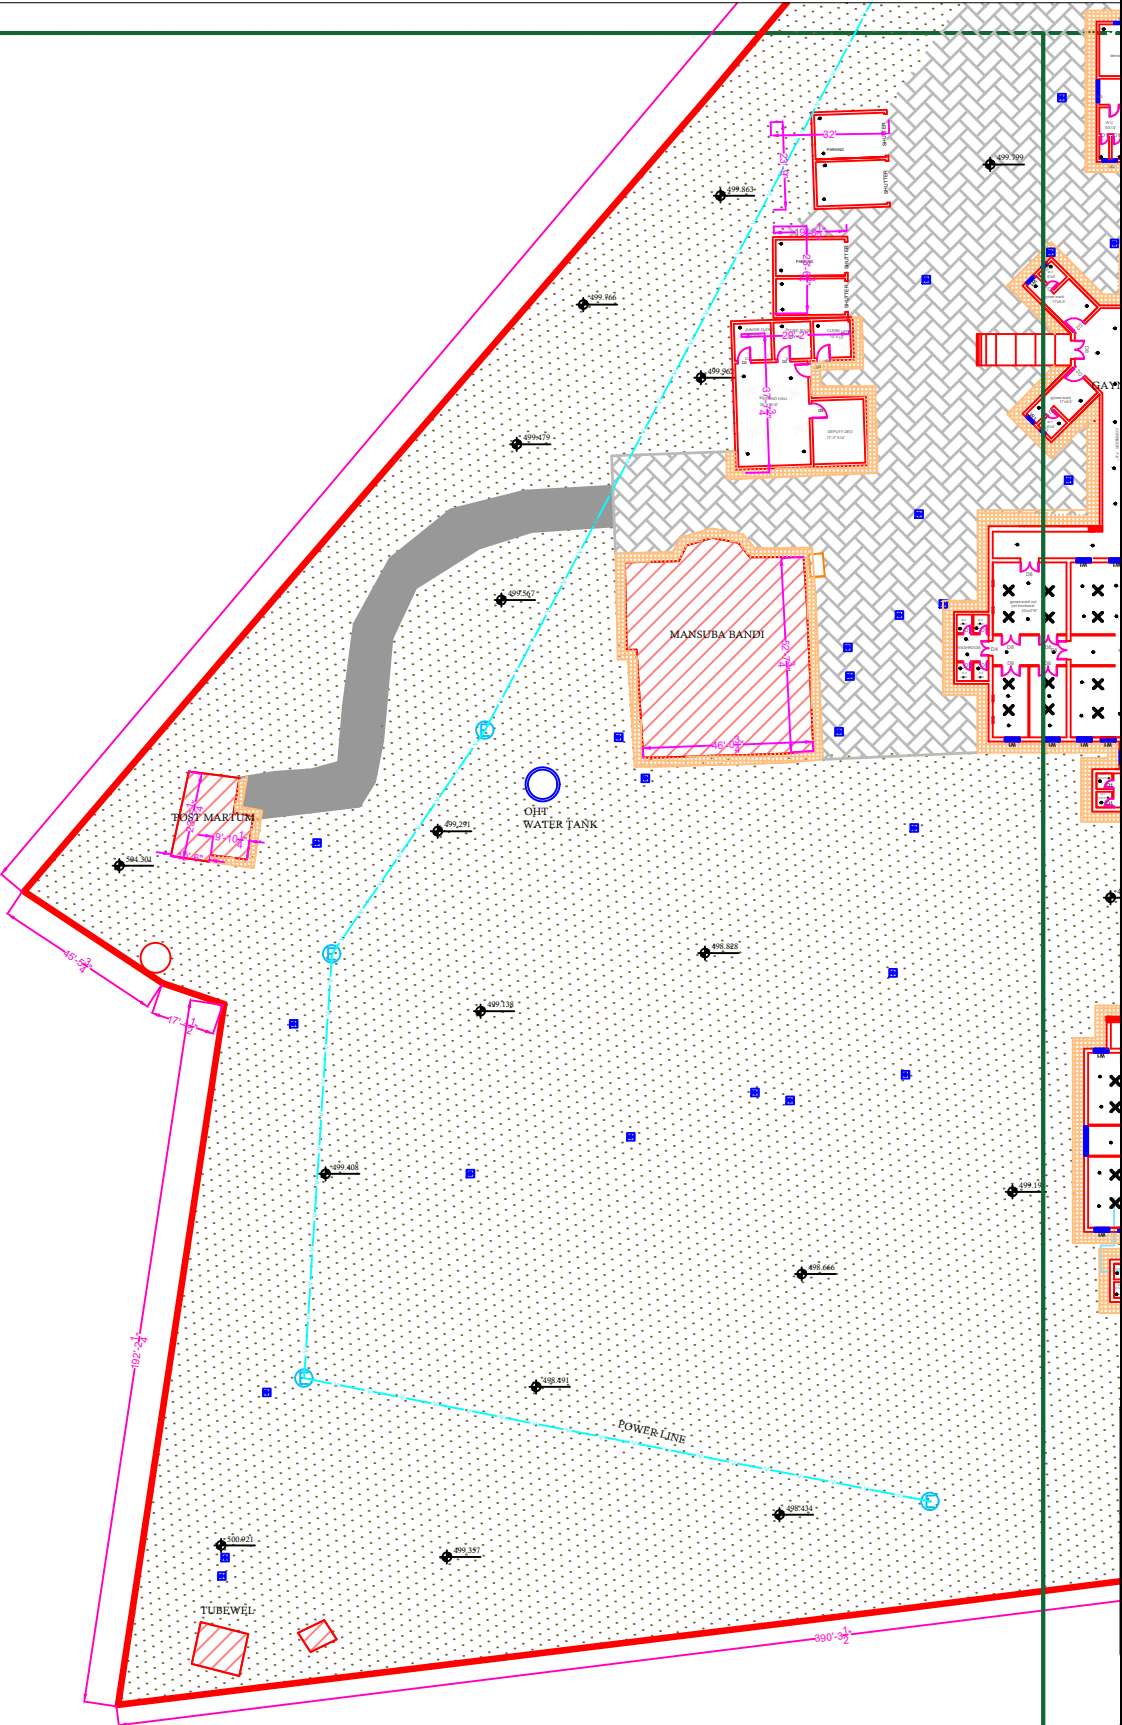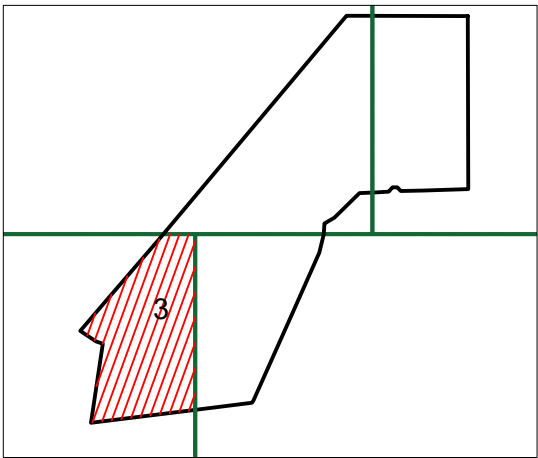

Legends:

Residential Area	
Road	
Wall	
Power Line	
OHT	
Tree	
Man Hole	
Tube Well	
Light Pole	
Lawns	
Earthen Areas	
Asphalts Roads	
Tough Pavers	
P.C.C / Plinth Protection	
Boundary Wall	
Brick Pavers / Soling	
Drain	
Tap	
Hand Pump	
Air Conditioner	
Tube Light	
Fan	
Roof Light	
Bulb	

AREA	
AREA WITHIN BOUNDARY WALL	420042.65 Sft
AREA OF CLINICAL BLOCK	38054.4 Sft
PLINTH AREA OF BLOCK	38054.4 Sft

OPENING SCHEDULE OF DOORS AND WINDOWS					
DOORS	WIDTH	HEIGHT	WINDOWS	WIDTH	HEIGHT
D1	2'-0"	7'-0"	W1	3'-0"	2'-6"
D2	3'-6"	7'-0"	W2	4'-0"	3'-0"
D3	3'-0"	7'-0"	W3	6'-0"	4'-0"
D4	4'-0"	7'-0"	W4	8'-0"	5'-0"
D5	4'-6"	7'-0"	W5		
D6	2'-6"	7'-0"	W6		
D7	6'-0"	7'-0"	W7		
D8	5'-0"	7'-0"	V1	2'-0"	2'-0"
D9			V2		

Project:
**CAD MAPPING OF TEHSIL
HEAD QUARTER HOSPITALS,
PUNJAB**



Client: GOVERNMENT OF THE PUNJAB PRIMARY & SECONDARY HEALTHCARE DEPARTMENT	Consultant: SKAFS CONSULTANT (Pvt.) Limited ENGINEERING AND ENVIRONMENT CONSULTANT
---	--

Drawing Title:
**THQ KALLUR KOT
HOSPITAL MASTER PLAN PART 3**

Drawing No.
SKAFS/KALLUR KOT/06

MASTER PLAN OF THQ HOSPITAL KALLUR KOT

PART 4

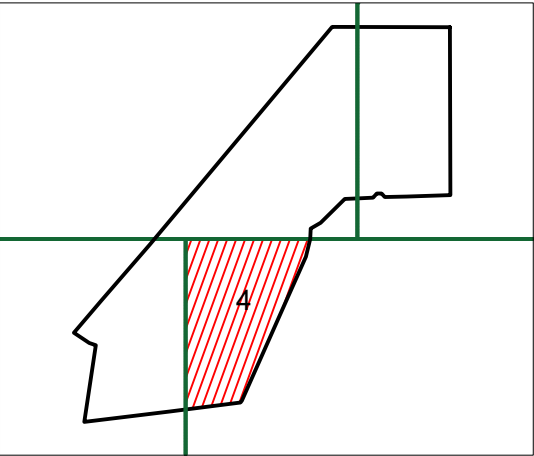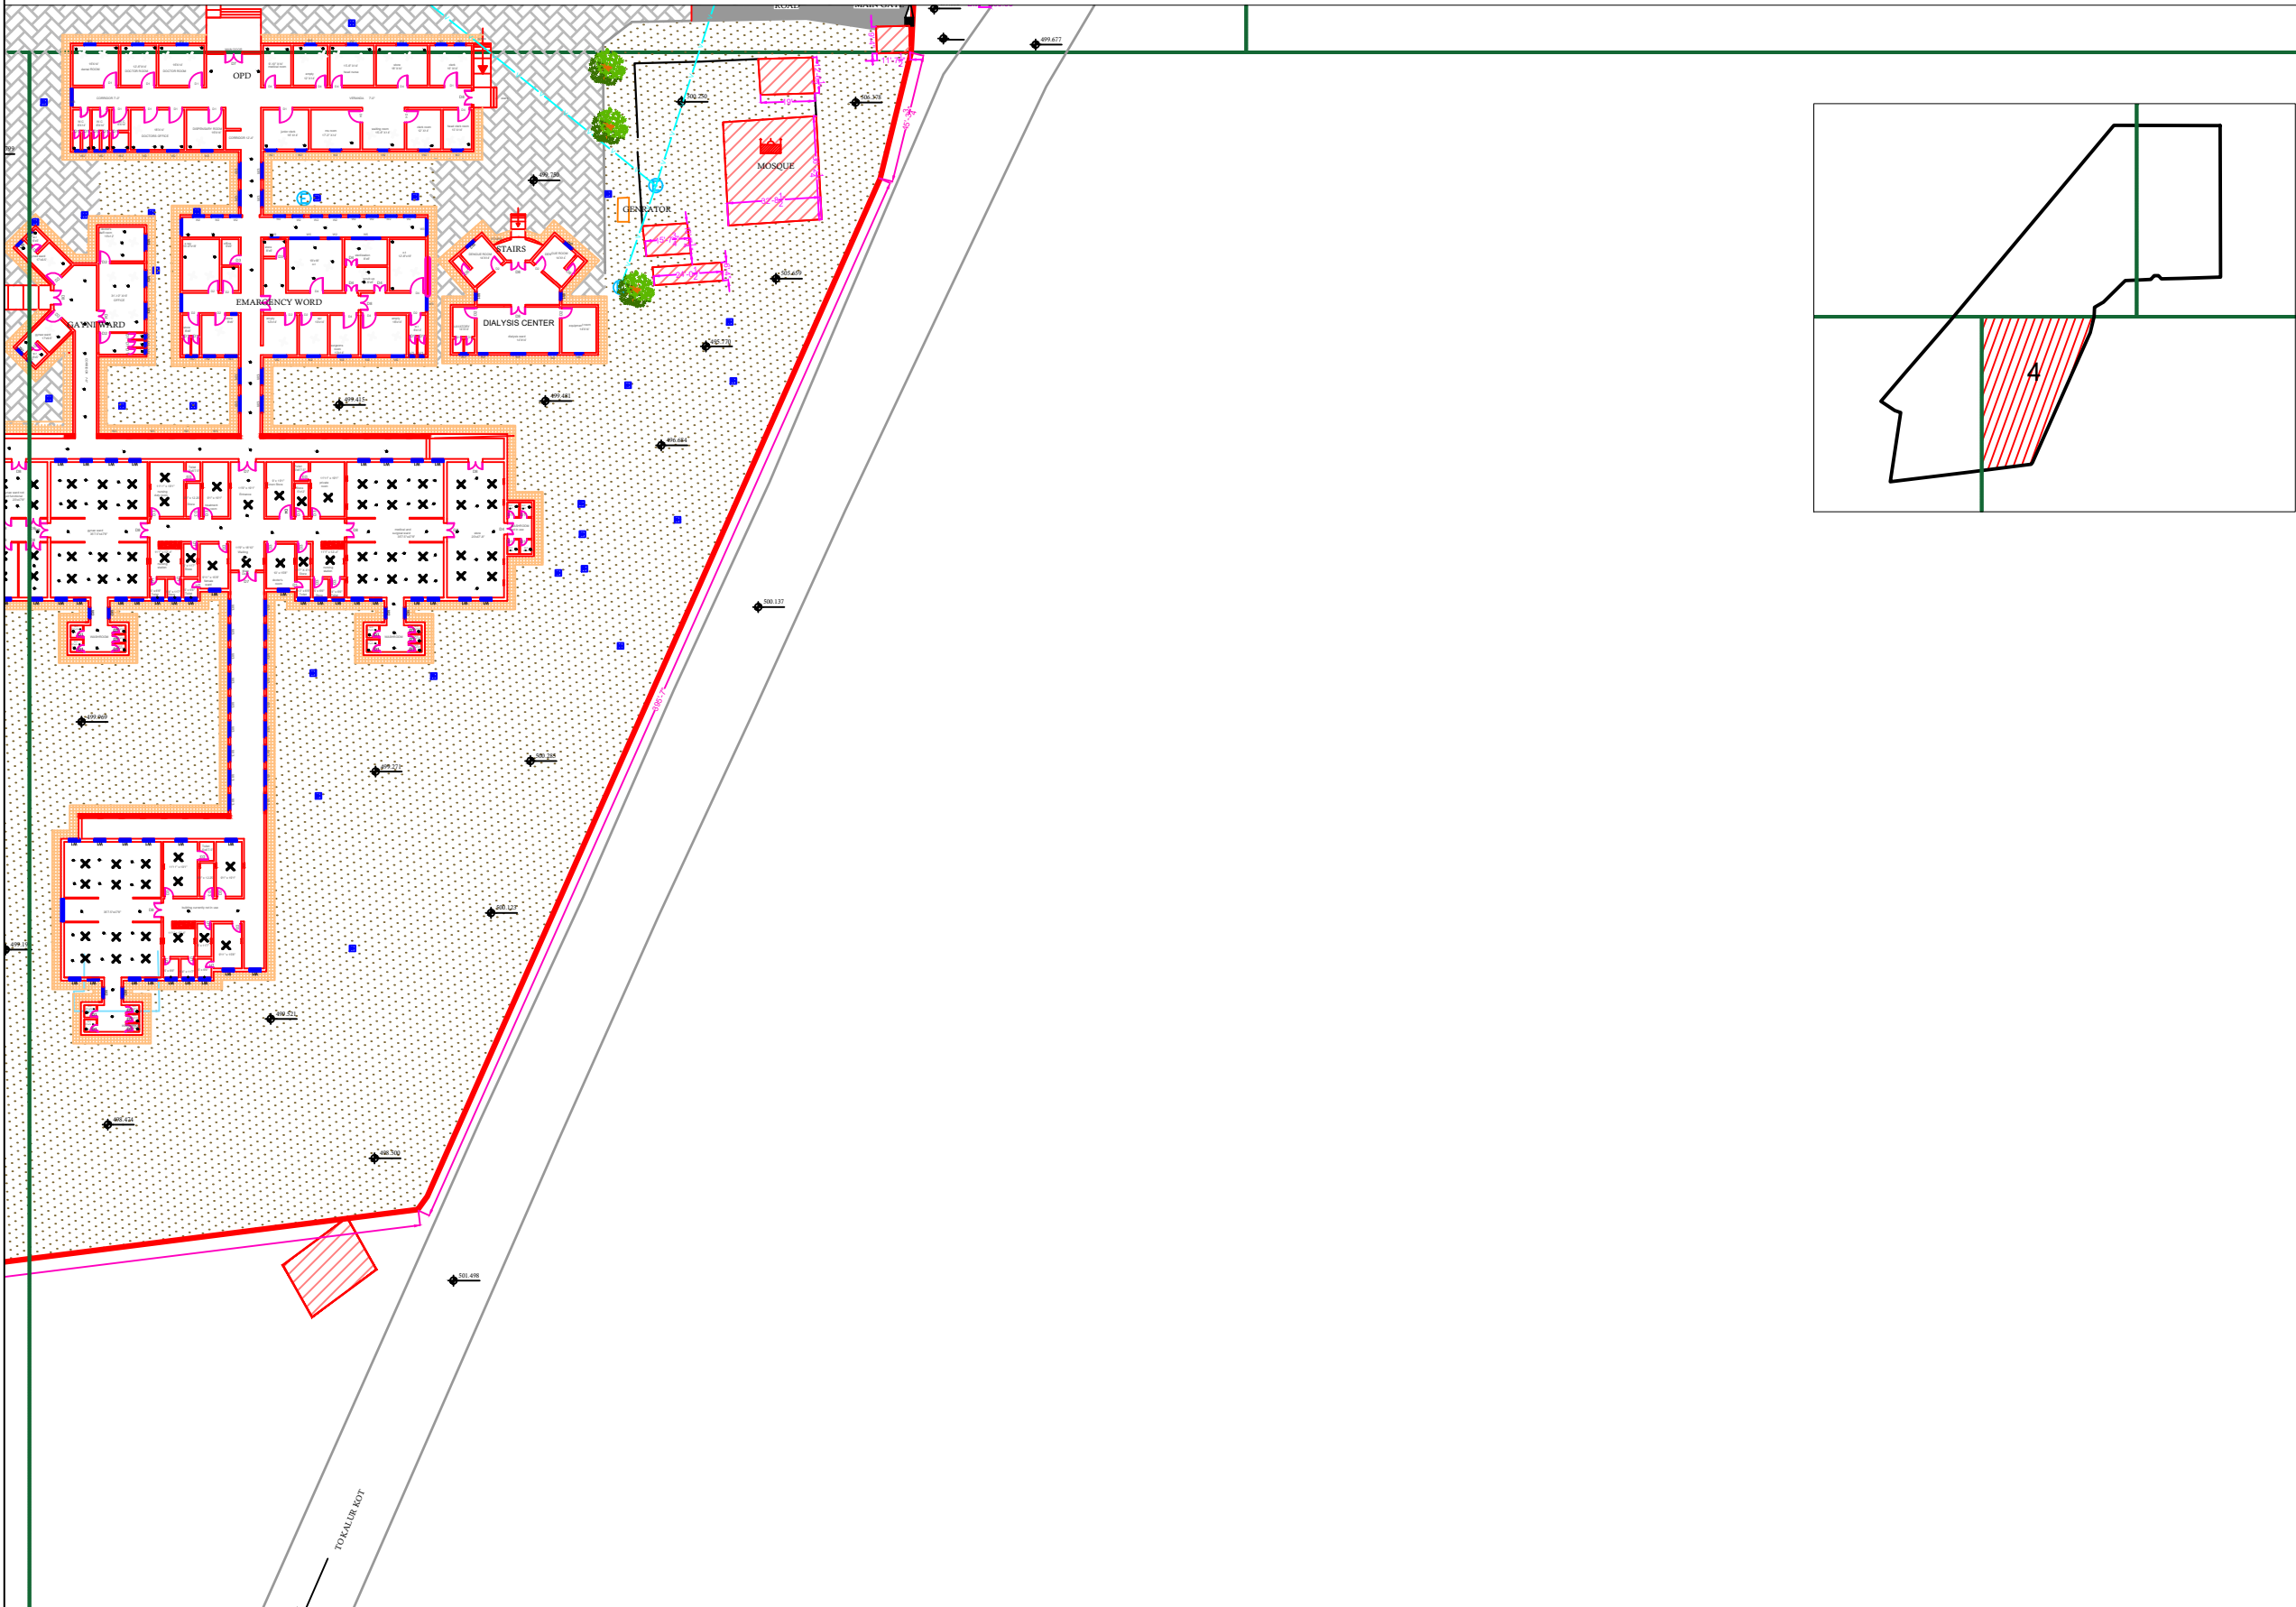

Legends:

Residential Area	
Road	
Wall	
Power Line	
OHT	
Tree	
Man Hole	
Tube Well	
Light Pole	
Lawns	
Earthen Areas	
Asphalts Roads	
Tough Pavers	
P.C.C / Plinth Protection	
Boundary Wall	
Brick Pavers / Soling	
Drain	
Tap	
Hand Pump	
Air Conditioner	
Tube Light	
Fan	
Roof Light	
Bulb	

AREA	
AREA WITHIN BOUNDARY WALL	420042.65 Sft
AREA OF CLINICAL BLOCK	38054.4 Sft
PLINTH AREA OF BLOCK	38054.4 Sft

OPENING SCHEDULE OF DOORS AND WINDOWS					
DOORS	WIDTH	HEIGHT	WINDOWS	WIDTH	HEIGHT
D1	2'-0"	7'-0"	W1	3'-0"	2'-6"
D2	3'-6"	7'-0"	W2	4'-0"	3'-0"
D3	3'-0"	7'-0"	W3	6'-0"	4'-0"
D4	4'-0"	7'-0"	W4	8'-0"	5'-0"
D5	4'-6"	7'-0"	W5		
D6	2'-6"	7'-0"	W6		
D7	6'-0"	7'-0"	W7		
D8	5'-0"	7'-0"	V1	2'-0"	2'-0"
D9			V2		

Project:
**CAD MAPPING OF TEHSIL
HEAD QUARTER HOSPITALS,
PUNJAB**

Client: GOVERNMENT OF THE PUNJAB PRIMARY & SECONDARY HEALTHCARE DEPARTMENT	Consultant: SKAFS CONSULTANT (Pvt.) Limited ENGINEERING AND ENVIRONMENT CONSULTANT
---	--

Drawing Title:
**THQ KALLUR KOT
HOSPITAL MASTER PLAN PART 4**

Drawing No.
SKAFS/KALLUR KOT/07

CLINICAL BLOCK OF THQ HOSPITAL KALLUR KOT


GROUND FLOOR

PART 1

PART 2

PART 3

PART 4

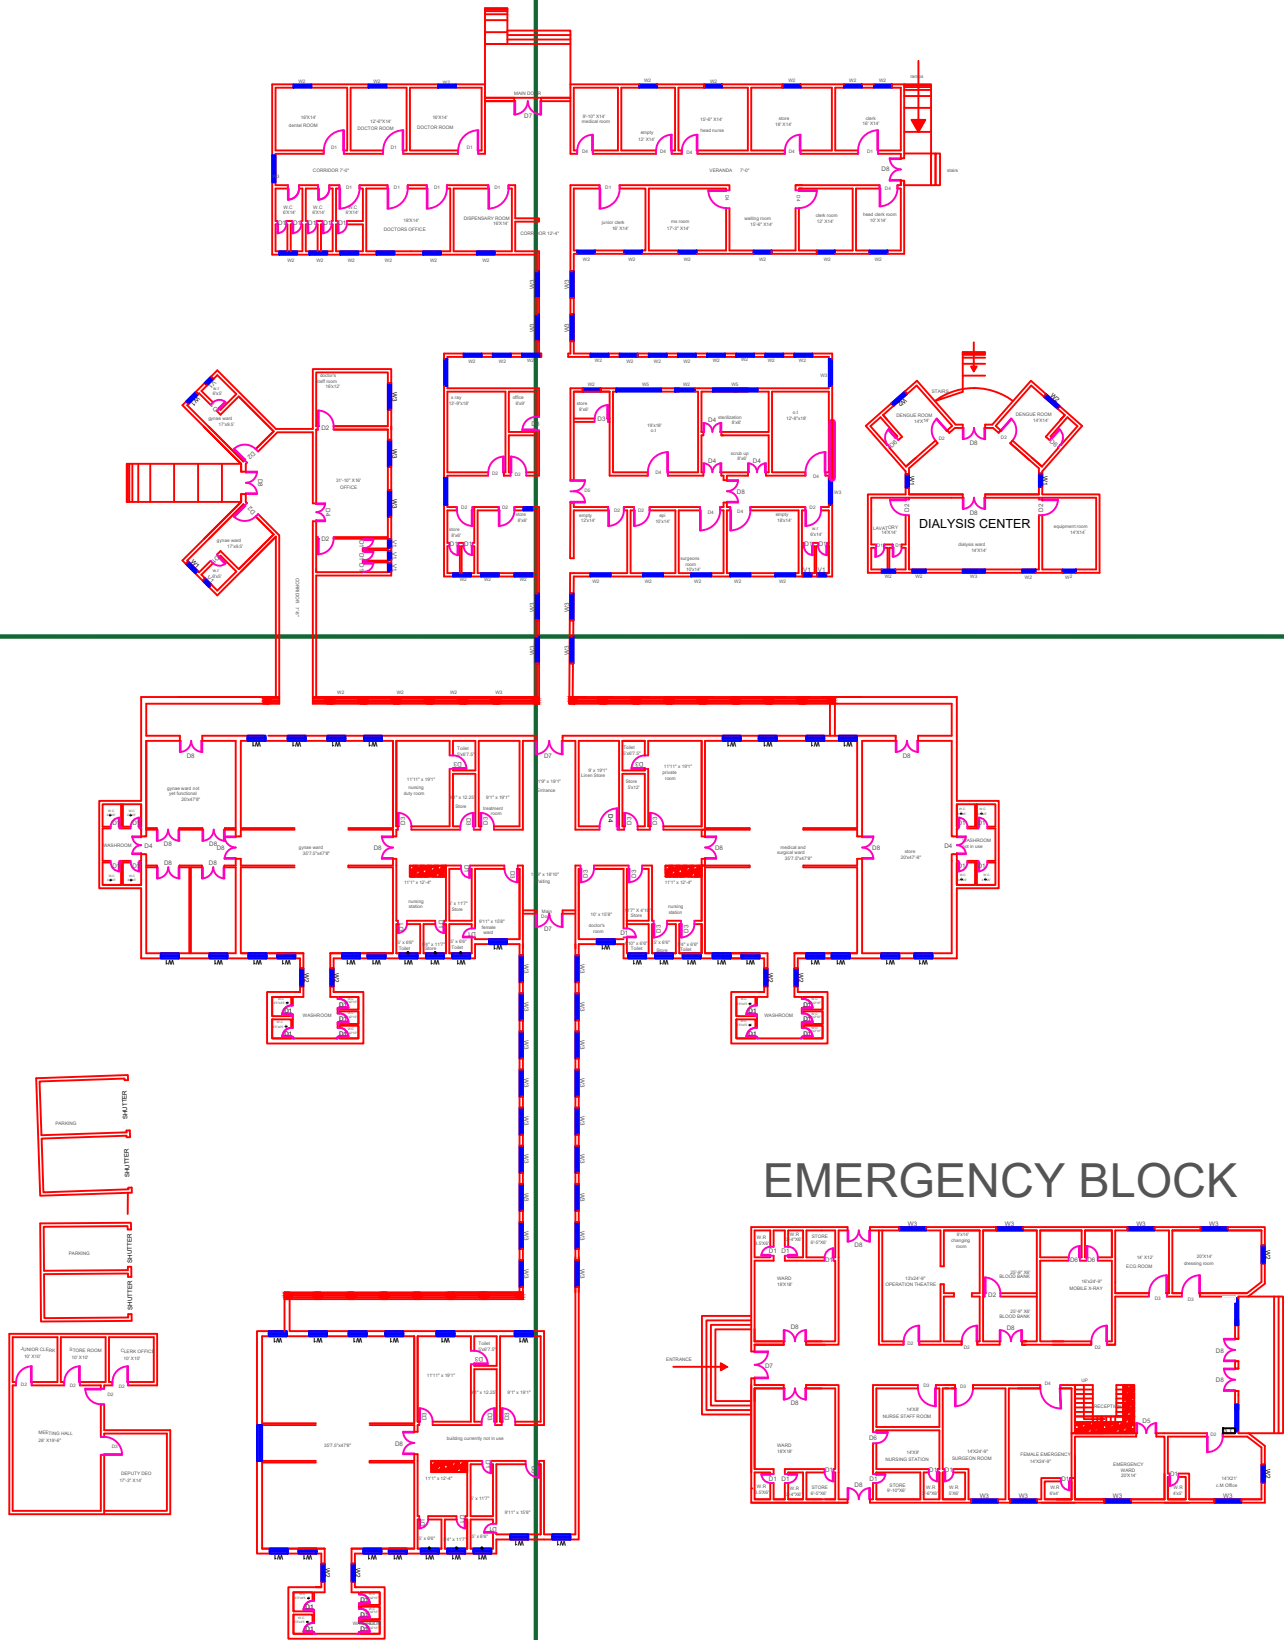

Legends:	
Residential Area	
Road	
Wall	
Power Line	
OHT	
Tree	
Man Hole	
Tube Well	
Light Pole	
Lawns	
Earthen Areas	
Asphalts Roads	
Tough Pavers	
P.C.C / Plinth Protection	
Boundary Wall	
Brick Pavers / Soling	
Drain	
Tap	
Hand Pump	
Air Conditioner	
Tube Light	
Fan	
Roof Light	
Bulb	

AREA	
AREA WITHIN BOUNDARY WALL	420042.65 Sft
AREA OF CLINICAL BLOCK	38054.4 Sft
PLINTH AREA OF BLOCK	38054.4 Sft

OPENING SCHEDULE OF DOORS AND WINDOWS					
DOORS	WIDTH	HEIGHT	WINDOWS	WIDTH	HEIGHT
D1	2'-0"	7'-0"	W1	3'-0"	2'-6"
D2	3'-6"	7'-0"	W2	4'-0"	3'-0"
D3	3'-0"	7'-0"	W3	6'-0"	4'-0"
D4	4'-0"	7'-0"	W4	8'-0"	5'-0"
D5	4'-6"	7'-0"	W5		
D6	2'-6"	7'-0"	W6		
D7	6'-0"	7'-0"	W7		
D8	5'-0"	7'-0"	V1	2'-0"	2'-0"
D9			V2		

Project:
**CAD MAPPING OF TEHSIL
HEAD QUARTER HOSPITALS,
PUNJAB**


Client: GOVERNMENT OF THE PUNJAB PRIMARY & SECONDARY HEALTHCARE DEPARTMENT	Consultant: SKAFS CONSULTANT (Pvt.) Limited ENGINEERING AND ENVIRONMENT CONSULTANT
---	--

Drawing Title:
**THQ KALLUR KOT
HOSPITAL CLINICAL BLOCK PLAN**

Drawing No.
SKAFS/KALLUR KOT/08

CLINICAL BLOCK OF THQ HOSPITAL KALLUR KOT

GROUND FLOOR PART 1

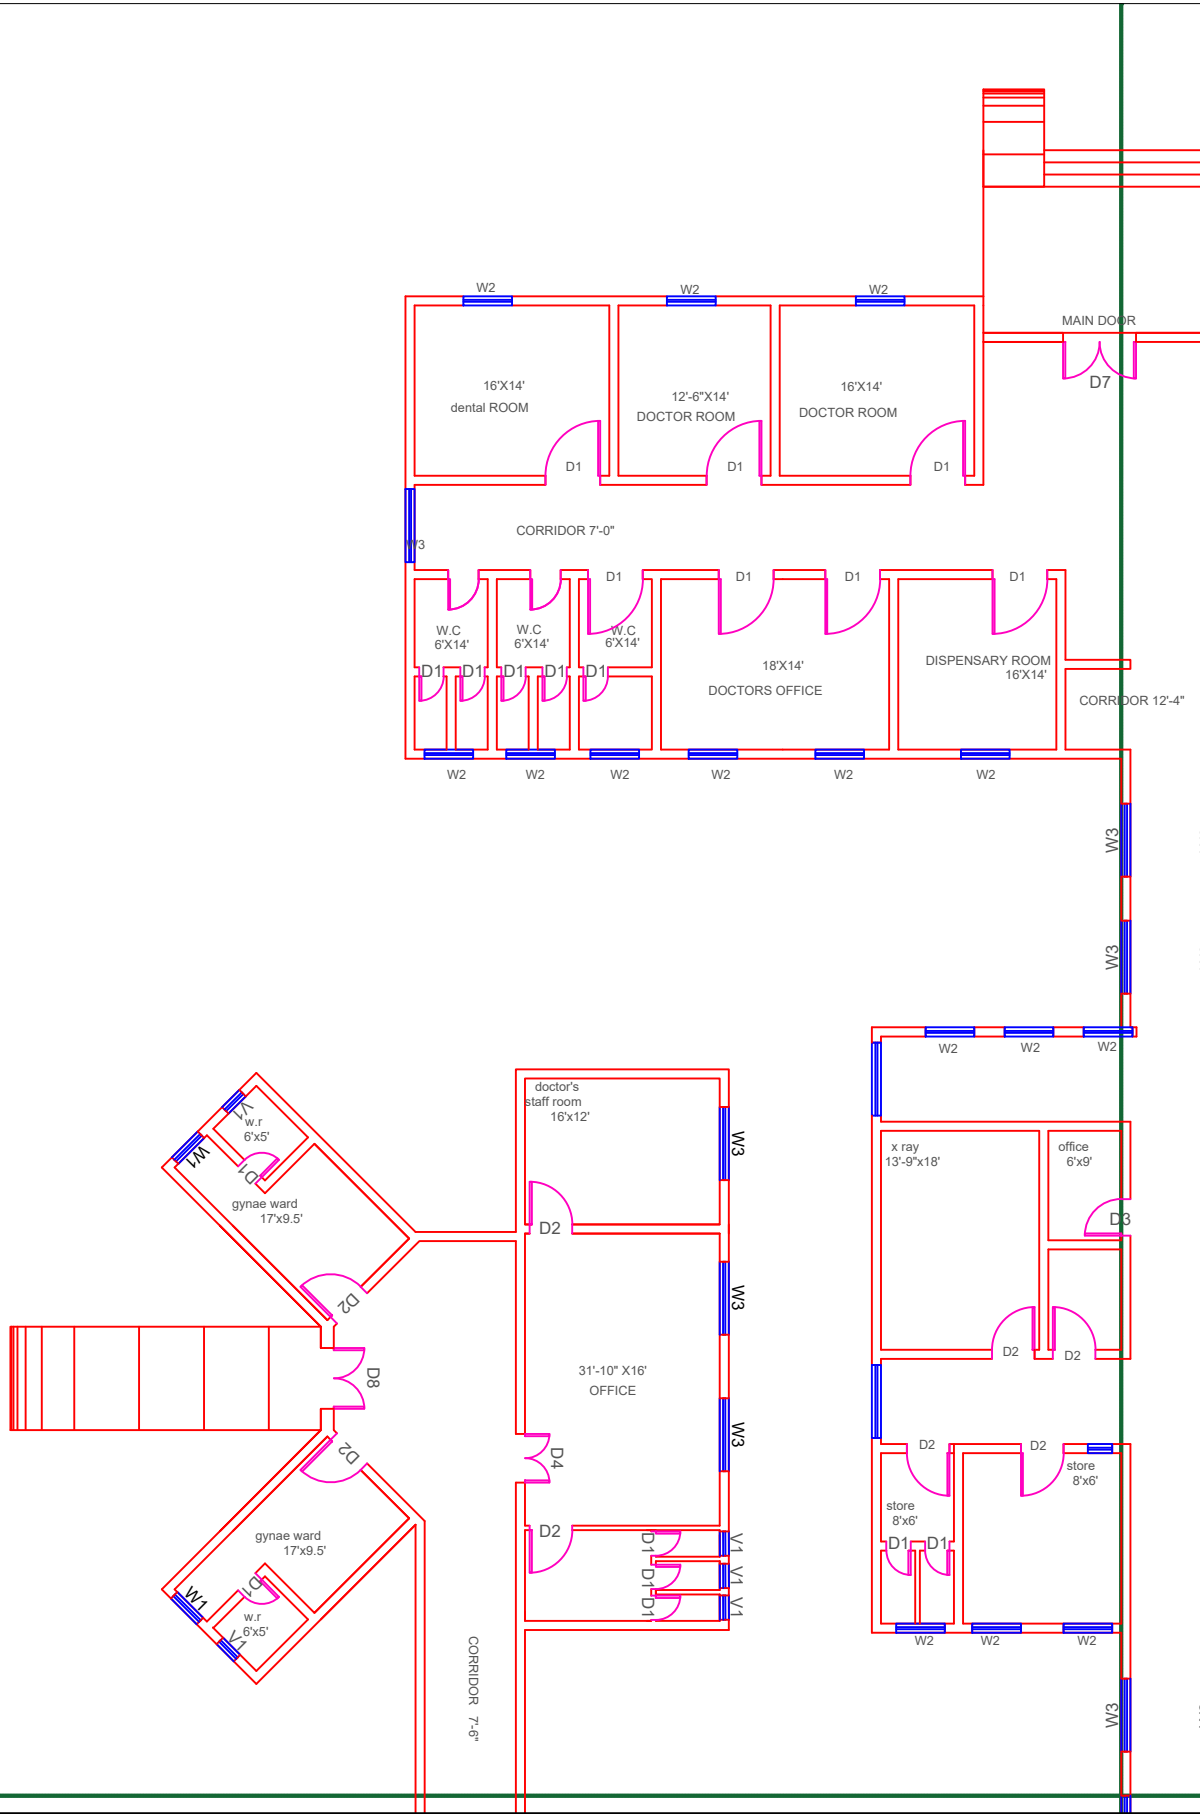

Legends:

Residential Area	
Road	
Wall	
Power Line	
OHT	
Tree	
Man Hole	
Tube Well	
Light Pole	
Lawns	
Earthen Areas	
Asphalts Roads	
Tough Pavers	
P.C.C / Plinth Protection	
Boundary Wall	
Brick Pavers / Soling	
Drain	
Tap	
Hand Pump	
Air Conditioner	
Tube Light	
Fan	
Roof Light	
Bulb	

AREA	
AREA WITHIN BOUNDARY WALL	420042.65 Sft
AREA OF CLINICAL BLOCK	38054.4 Sft
PLINTH AREA OF BLOCK	38054.4 Sft

OPENING SCHEDULE OF DOORS AND WINDOWS					
DOORS	WIDTH	HEIGHT	WINDOWS	WIDTH	HEIGHT
D1	2'-0"	7'-0"	W1	3'-0"	2'-6"
D2	3'-6"	7'-0"	W2	4'-0"	3'-0"
D3	3'-0"	7'-0"	W3	6'-0"	4'-0"
D4	4'-0"	7'-0"	W4	8'-0"	5'-0"
D5	4'-6"	7'-0"	W5		
D6	2'-6"	7'-0"	W6		
D7	6'-0"	7'-0"	W7		
D8	5'-0"	7'-0"	V1	2'-0"	2'-0"
D9			V2		

Project:
**CAD MAPPING OF TEHSIL
HEAD QUARTER HOSPITALS,
PUNJAB**



Client: GOVERNMENT OF THE PUNJAB PRIMARY & SECONDARY HEALTHCARE DEPARTMENT	Consultant: SKAFS CONSULTANT (Pvt.) Limited ENGINEERING AND ENVIRONMENT CONSULTANT
---	--

Drawing Title:
**THQ KALLUR KOT
CLINICAL BLOCK PLAN (PART 1)**

Drawing No.
SKAFS/KALLUR KOT/09

CLINICAL BLOCK OF THQ HOSPITAL KALLUR KOT

GROUND FLOOR PART 2

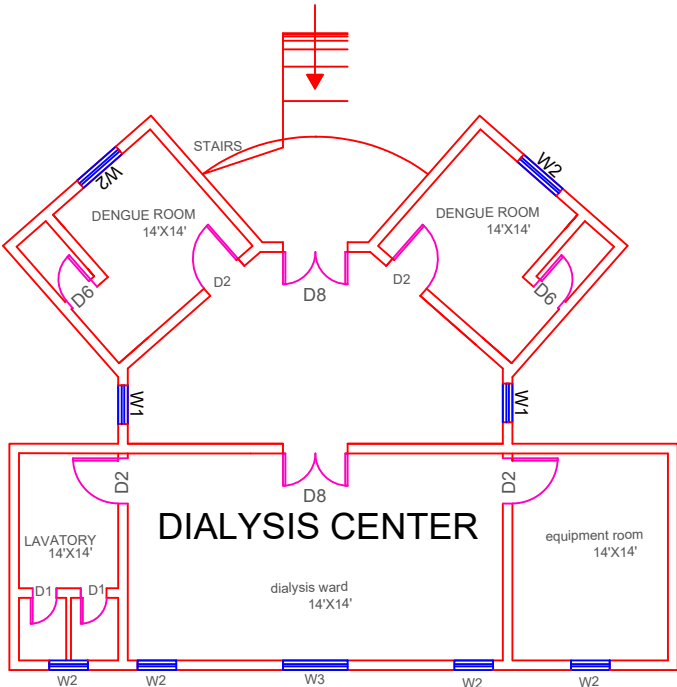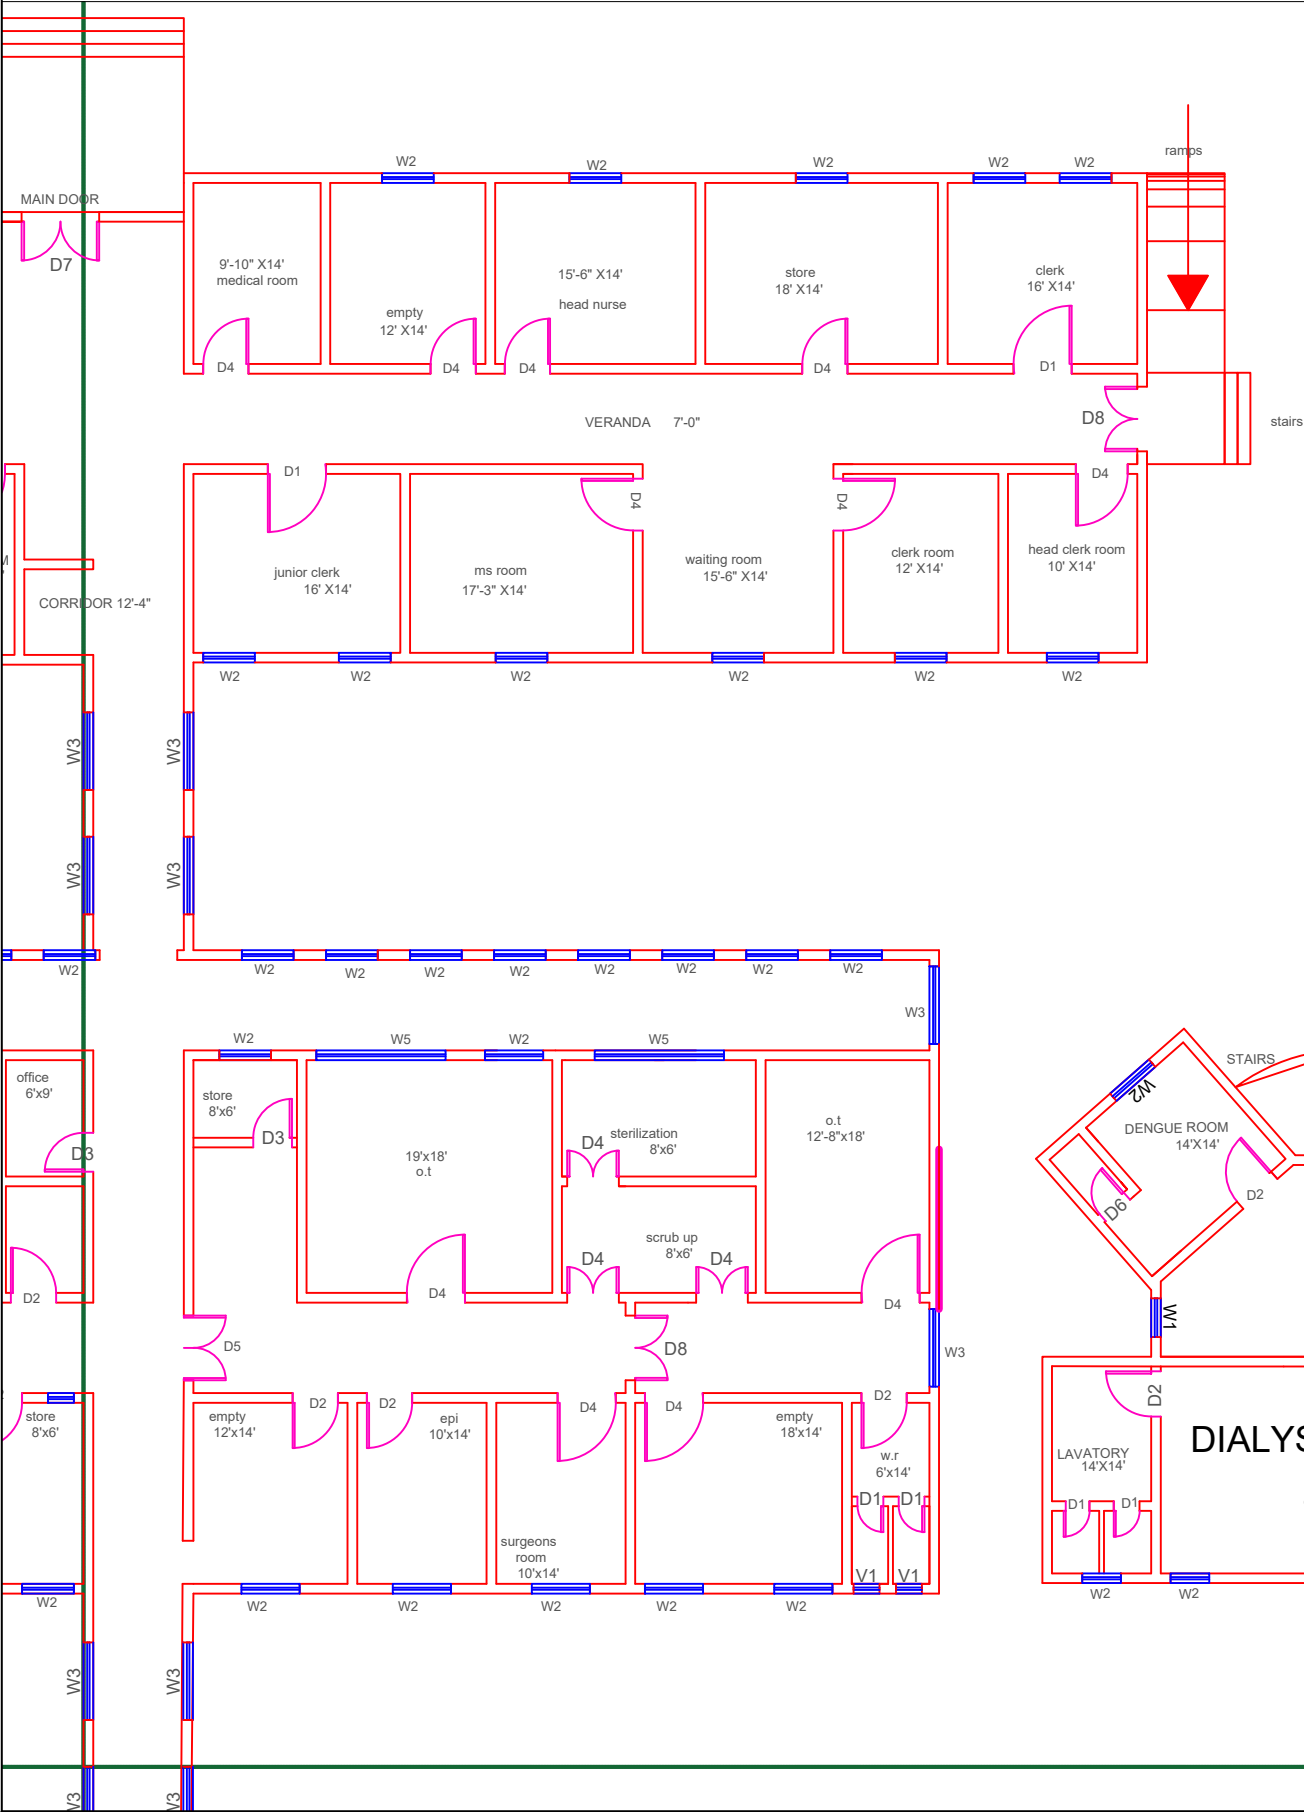

Legends:

Residential Area	
Road	
Wall	
Power Line	
OHT	
Tree	
Man Hole	
Tube Well	
Light Pole	
Lawns	
Earthen Areas	
Asphalts Roads	
Tough Pavers	
P.C.C / Plinth Protection	
Boundary Wall	
Brick Pavers / Soling	
Drain	
Tap	
Hand Pump	
Air Conditioner	
Tube Light	
Fan	
Roof Light	
Bulb	

AREA					
AREA WITHIN BOUNDARY WALL			420042.65 Sft		
AREA OF CLINICAL BLOCK			38054.4 Sft		
PLINTH AREA OF BLOCK			38054.4 Sft		
OPENING SCHEDULE OF DOORS AND WINDOWS					
DOORS	WIDTH	HEIGHT	WINDOWS	WIDTH	HEIGHT
D1	2'-0"	7'-0"	W1	3'-0"	2'-6"
D2	3'-6"	7'-0"	W2	4'-0"	3'-0"
D3	3'-0"	7'-0"	W3	6'-0"	4'-0"
D4	4'-0"	7'-0"	W4	8'-0"	5'-0"
D5	4'-6"	7'-0"	W5		
D6	2'-6"	7'-0"	W6		
D7	6'-0"	7'-0"	W7		
D8	5'-0"	7'-0"	V1	2'-0"	2'-0"
D9			V2		

Project:

CAD MAPPING OF TEHSIL
HEAD QUARTER HOSPITALS,
PUNJAB

Client:



GOVERNMENT OF THE PUNJAB
PRIMARY & SECONDARY
HEALTHCARE DEPARTMENT

Consultant:



SKAFS CONSULTANT (Pvt.)
Limited
ENGINEERING AND ENVIRONMENT
CONSULTANT


Drawing Title:

THQ KALLUR KOT
CLINICAL BLOCK PLAN (PART 2)

Drawing No.

SKAFS/KALLUR KOT/10

CLINICAL BLOCK OF THQ HOSPITAL KALLUR KOT
GROUND FLOOR PART 3

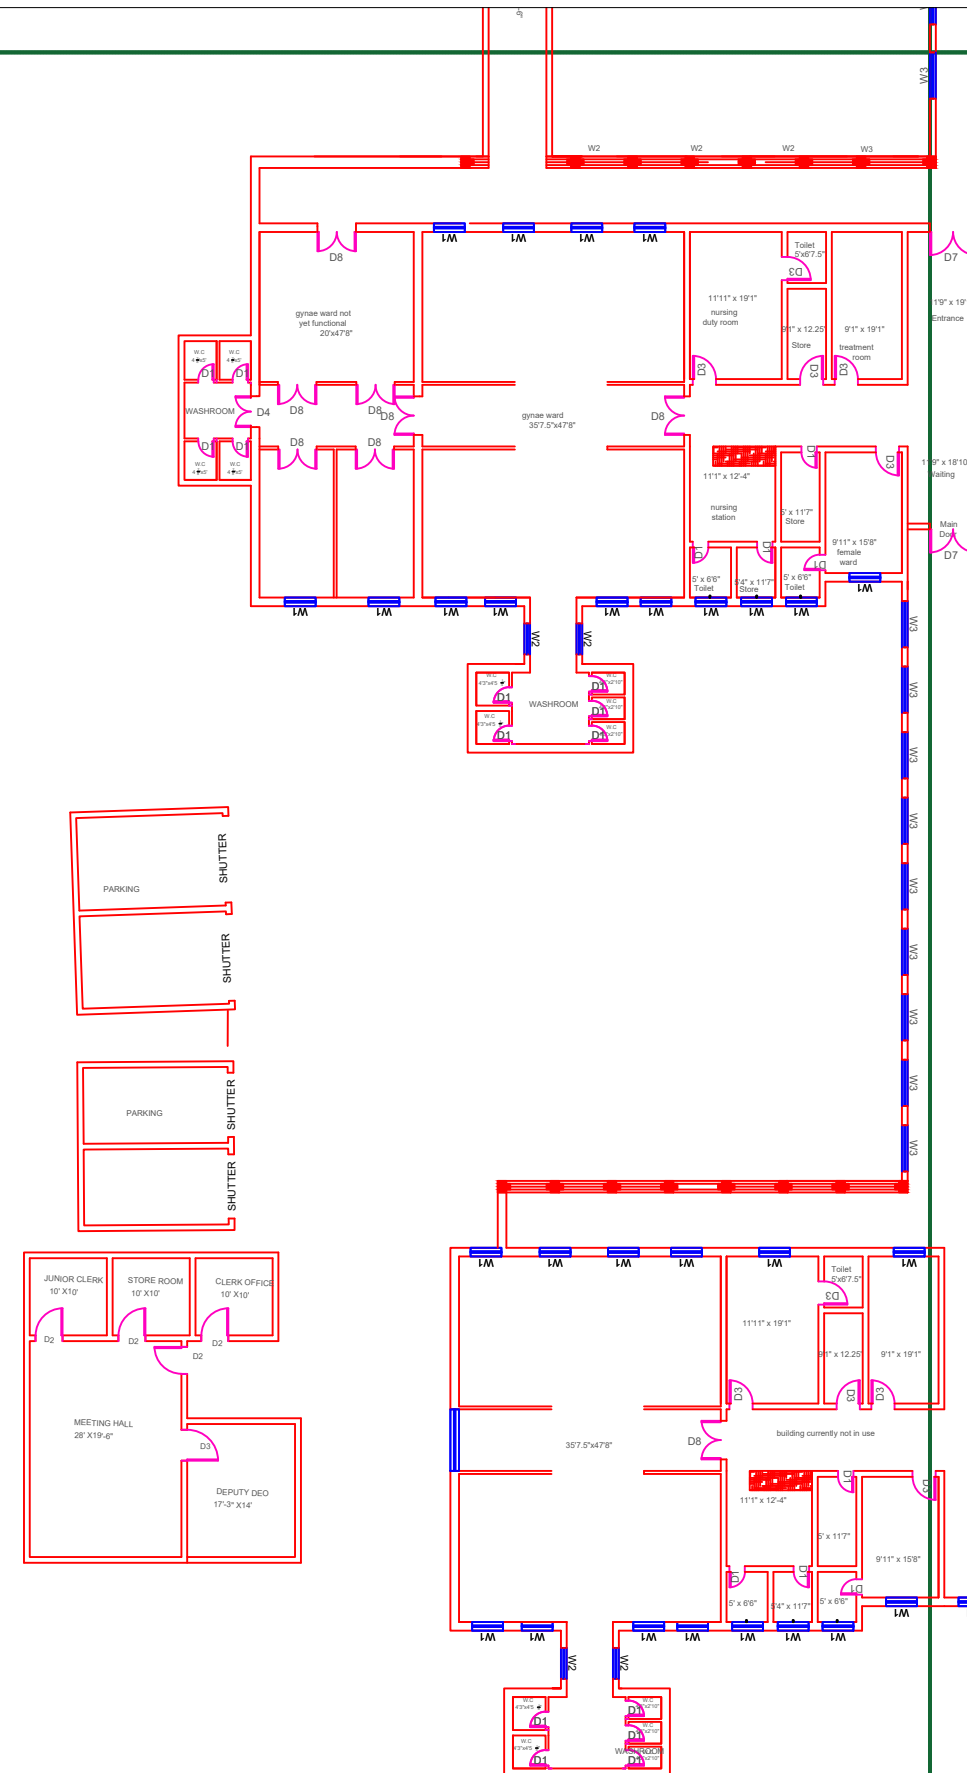

Legends:

Residential Area	
Road	
Wall	
Power Line	
OHT	
Tree	
Man Hole	
Tube Well	
Light Pole	
Lawns	
Earthen Areas	
Asphalts Roads	
Tough Pavers	
P.C.C / Plinth Protection	
Boundary Wall	
Brick Pavers / Soling	
Drain	
Tap	
Hand Pump	
Air Conditioner	
Tube Light	
Fan	
Roof Light	
Bulb	

AREA	
AREA WITHIN BOUNDARY WALL	420042.65 Sft
AREA OF CLINICAL BLOCK	38054.4 Sft
PLINTH AREA OF BLOCK	38054.4 Sft

OPENING SCHEDULE OF DOORS AND WINDOWS					
DOORS	WIDTH	HEIGHT	WINDOWS	WIDTH	HEIGHT
D1	2'-0"	7'-0"	W1	3'-0"	2'-6"
D2	3'-6"	7'-0"	W2	4'-0"	3'-0"
D3	3'-0"	7'-0"	W3	6'-0"	4'-0"
D4	4'-0"	7'-0"	W4	8'-0"	5'-0"
D5	4'-6"	7'-0"	W5		
D6	2'-6"	7'-0"	W6		
D7	6'-0"	7'-0"	W7		
D8	5'-0"	7'-0"	V1	2'-0"	2'-0"
D9			V2		

Project: **CAD MAPPING OF TEHSIL
HEAD QUARTER HOSPITALS,
PUNJAB**


Client:  GOVERNMENT OF THE PUNJAB PRIMARY & SECONDARY HEALTHCARE DEPARTMENT	Consultant:  SKAFS CONSULTANT (Pvt.) Limited ENGINEERING AND ENVIRONMENT CONSULTANT.
--	--

Drawing Title:	THQ KALLUR KOT CLINICAL BLOCK PLAN (PART 3)
----------------	--


Drawing No.	SKAFS/KALLUR KOT/11
-------------	----------------------------

CLINICAL BLOCK OF THQ HOSPITAL KALLUR KOT

GROUND FLOOR PART 4

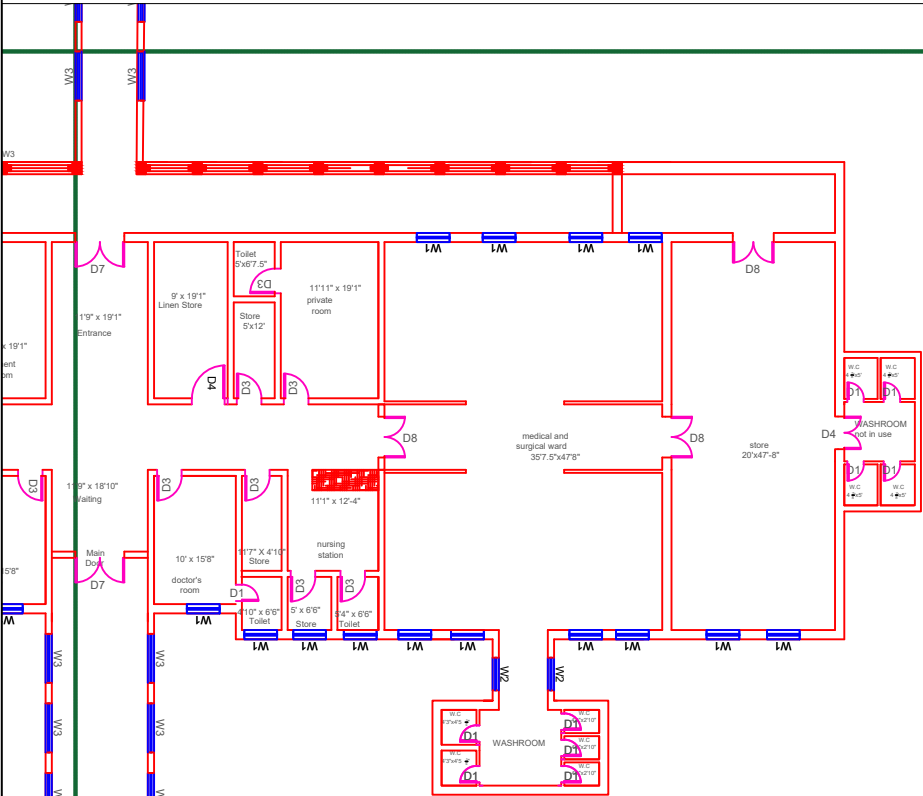

EMERGENCY BLOCK

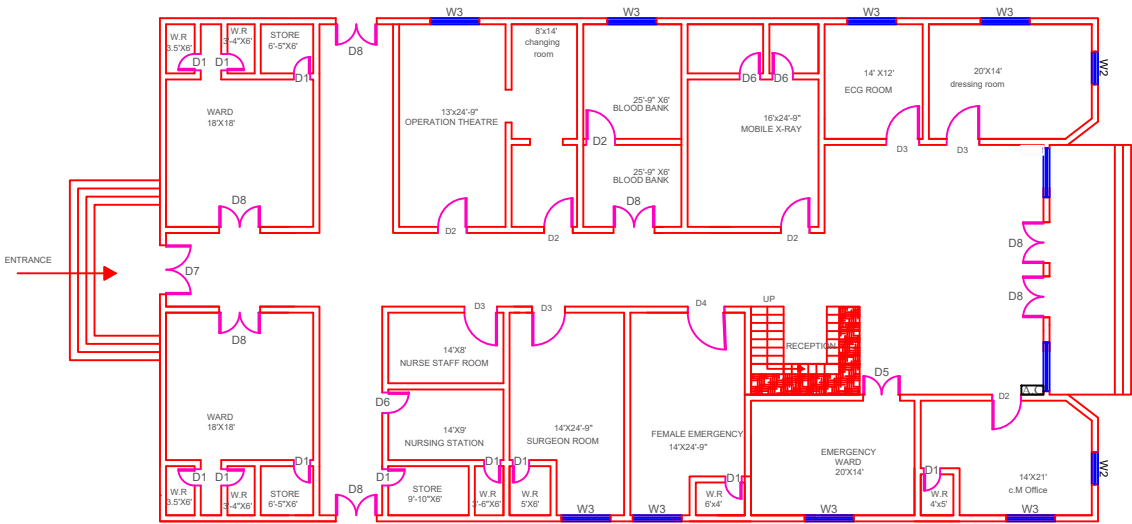

Legends:

Residential Area	
Road	
Wall	
Power Line	
OHT	
Tree	
Man Hole	
Tube Well	
Light Pole	
Lawns	
Earthen Areas	
Asphalts Roads	
Tough Pavers	
P.C.C / Plinth Protection	
Boundary Wall	
Brick Pavers / Soling	
Drain	
Tap	
Hand Pump	
Air Conditioner	
Tube Light	
Fan	
Roof Light	
Bulb	

AREA

AREA WITHIN BOUNDARY WALL	420042.65 Sft
AREA OF CLINICAL BLOCK	38054.4 Sft
PLINTH AREA OF BLOCK	38054.4 Sft

OPENING SCHEDULE OF DOORS AND WINDOWS

DOORS	WIDTH	HEIGHT	WINDOWS	WIDTH	HEIGHT
D1	2'-0"	7'-0"	W1	3'-0"	2'-6"
D2	3'-6"	7'-0"	W2	4'-0"	3'-0"
D3	3'-0"	7'-0"	W3	6'-0"	4'-0"
D4	4'-0"	7'-0"	W4	8'-0"	5'-0"
D5	4'-6"	7'-0"	W5		
D6	2'-6"	7'-0"	W6		
D7	6'-0"	7'-0"	W7		
D8	5'-0"	7'-0"	V1	2'-0"	2'-0"
D9			V2		

Project:
**CAD MAPPING OF TEHSIL
HEAD QUARTER HOSPITALS,
PUNJAB**


Client: GOVERNMENT OF THE PUNJAB PRIMARY & SECONDARY HEALTHCARE DEPARTMENT	Consultant: SKAFS CONSULTANT (Pvt.) Limited ENGINEERING AND ENVIRONMENT CONSULTANT
---	--

Drawing Title:
**THQ KALLUR KOT
CLINICAL BLOCK PLAN (PART 4)**

Drawing No.
SKAFS/KALLUR KOT/12

ELECTRICAL LAYOUT PLAN OF THQ HOSPITAL KALLUR KOT

GROUND FLOOR

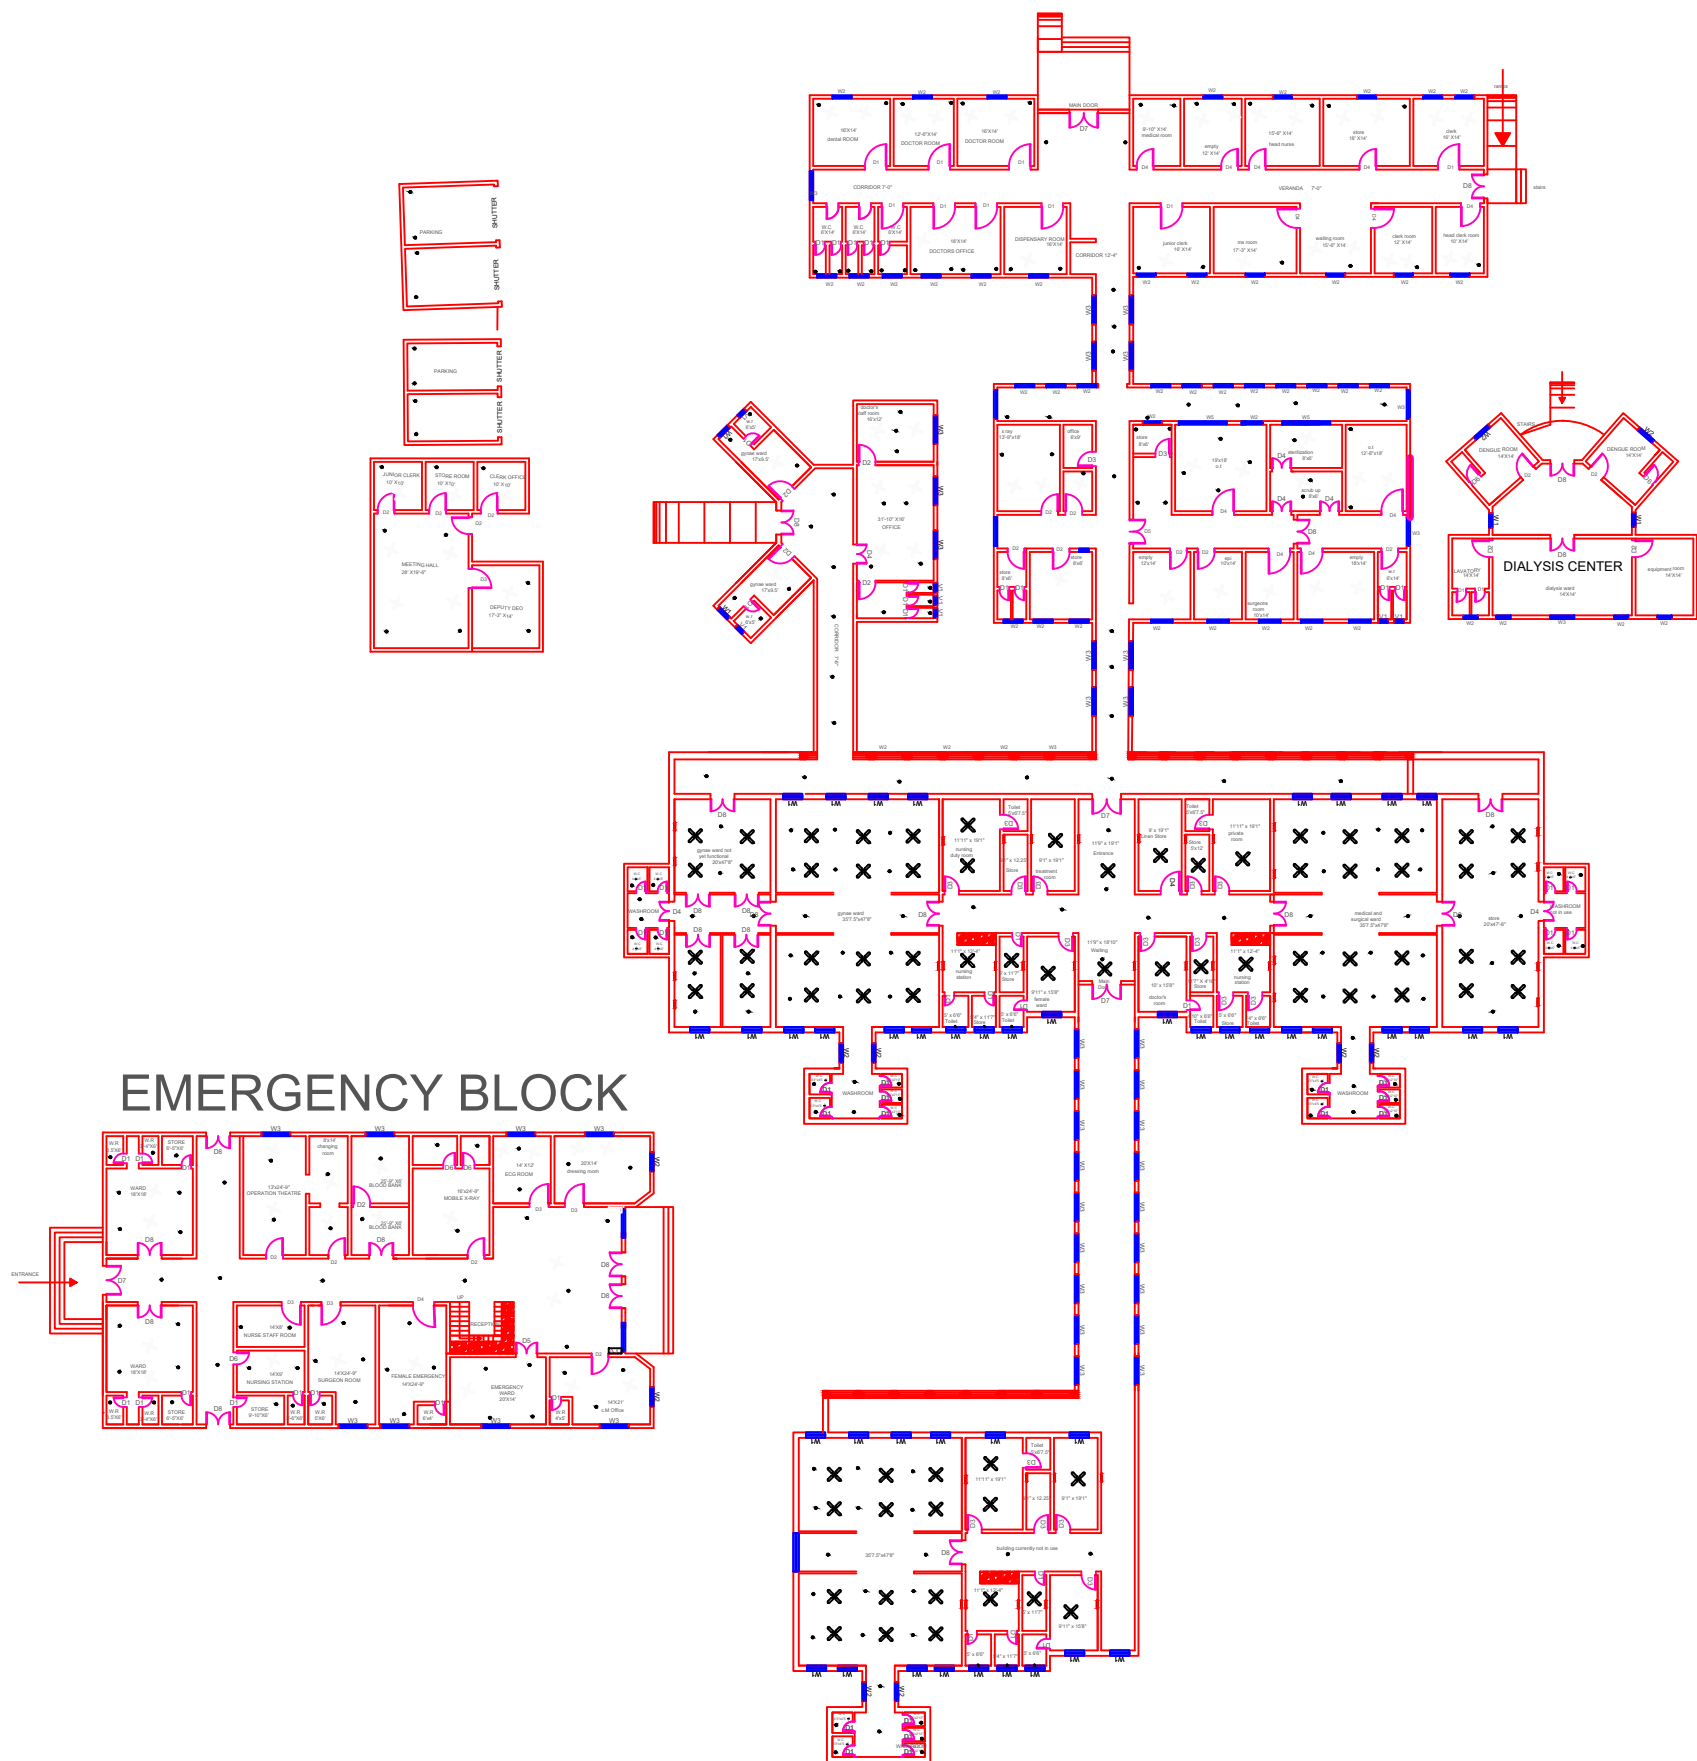

Legends:

Residential Area	
Road	
Wall	
Power Line	
OHT	
Tree	
Man Hole	
Tube Well	
Light Pole	
Lawns	
Earthen Areas	
Asphalts Roads	
Tough Pavers	
P.C.C / Plinth Protection	
Boundary Wall	
Brick Pavers / Soling	
Drain	
Tap	
Hand Pump	
Air Conditioner	
Tube Light	
Fan	
Roof Light	
Bulb	

AREA

AREA WITHIN BOUNDARY WALL	420042.65 Sft
AREA OF CLINICAL BLOCK	38054.4 Sft
PLINTH AREA OF BLOCK	38054.4 Sft

OPENING SCHEDULE OF DOORS AND WINDOWS

DOORS	WIDTH	HEIGHT	WINDOWS	WIDTH	HEIGHT
D1	2'-0"	7'-0"	W1	3'-0"	2'-6"
D2	3'-6"	7'-0"	W2	4'-0"	3'-0"
D3	3'-0"	7'-0"	W3	6'-0"	4'-0"
D4	4'-0"	7'-0"	W4	8'-0"	5'-0"
D5	4'-6"	7'-0"	W5		
D6	2'-6"	7'-0"	W6		
D7	6'-0"	7'-0"	W7		
D8	5'-0"	7'-0"	V1	2'-0"	2'-0"
D9			V2		

Project:
**CAD MAPPING OF TEHSIL
HEAD QUARTER HOSPITALS,
PUNJAB**

Client:

GOVERNMENT OF THE PUNJAB
PRIMARY & SECONDARY
HEALTHCARE DEPARTMENT

Consultant:

SKAFS CONSULTANT (Pvt.)
Limited
ENGINEERING AND ENVIRONMENT
CONSULTANT

Drawing Title:
**THQ KALLUR KOT
ELECTRICAL PLAN (GROUND FLOOR)**

Drawing No.
SKAFS/KALLUR KOT/13