


MASTER PLAN OF THQ HOSPITAL KOTLI SATTIAN

PART 1

PART 2

PART 3

PART 4

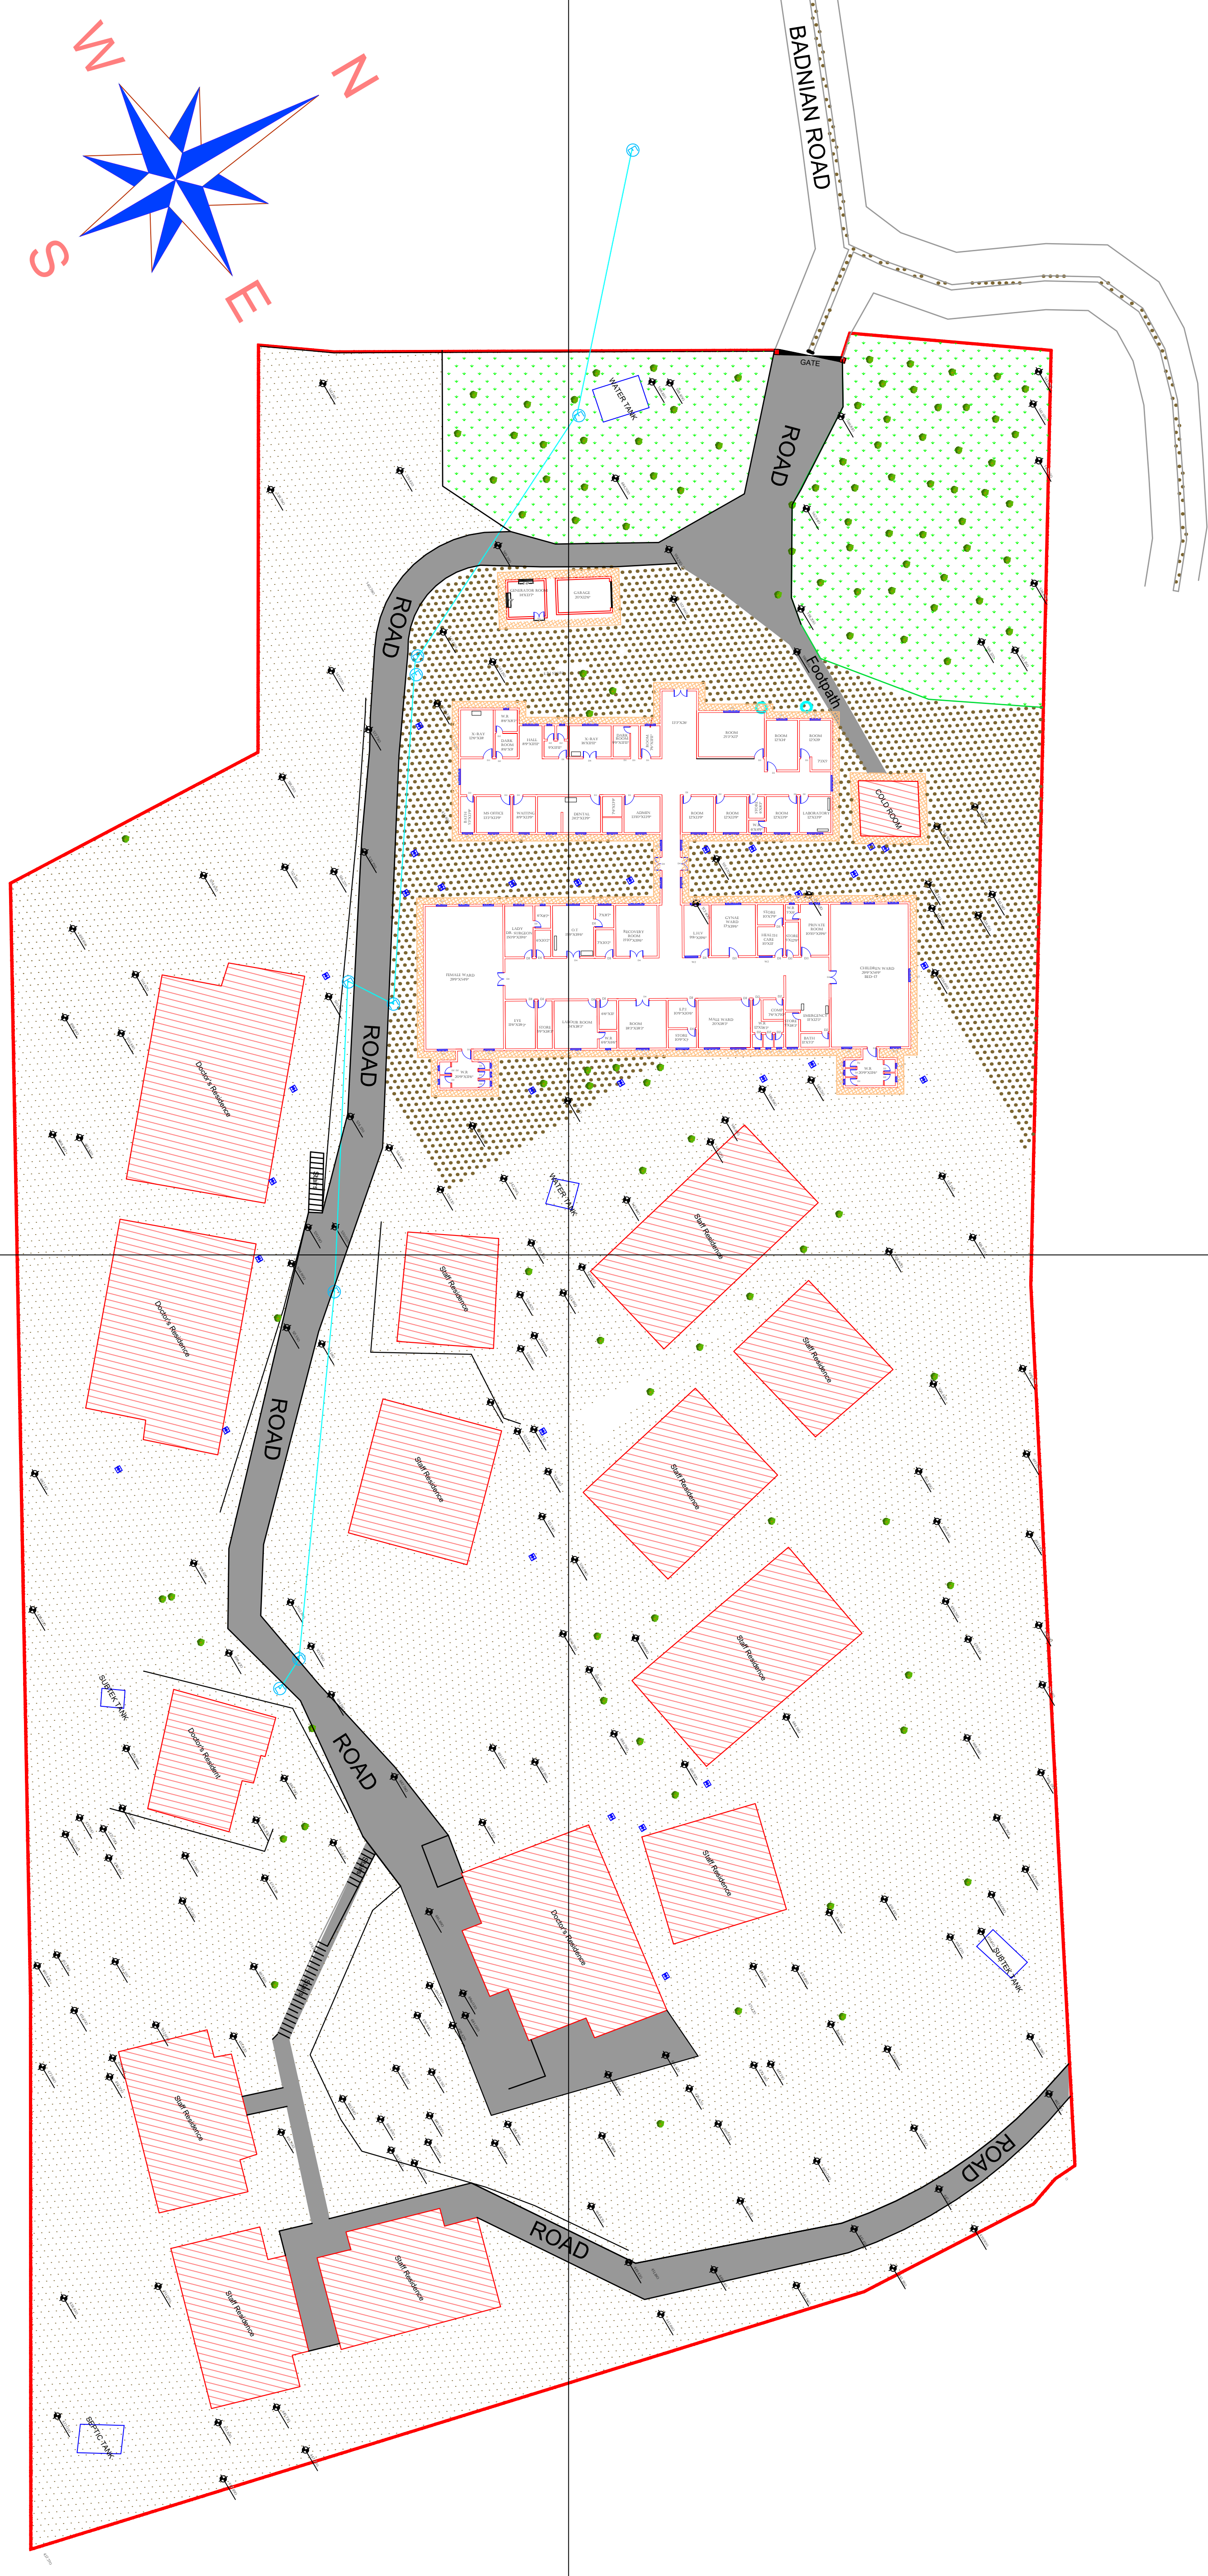

Legends:

RESIDENTIAL AREA	
ROAD	
WALL	
POWER LINE	
OHT	
TREE	
MANHOLE	
TUBE WELL	
LIGHT POLE	
LAWNS	
EARTHEN AREAS	
ASPHALTS ROADS	
TOUGH PAVERS	
P.C.C /PLINTH PROTECTION	
BOUNDARY WALL	
TAP	
HAND PUMP	
BRICK PAVERS	
AIR CONDITIONER	
TUBE LIGHT	
FAN	
ROOF LIGHT	
BULB	

AREA	
AREA WITHIN BOUNDARY WALL	292181.07 SFT
AREA OF CLINICAL BLOCK	22149.16 SFT
PLINTH AREA OF BLOCK	SFT

OPENING SCHEDULE OF DOORS AND WINDOWS					
DOORS	WIDTH	HEIGHT	WINDOWS	WIDTH	HEIGHT
D1	3'-6"	7'-0"	W1	4'-0"	2'-6"
D2	2'-6"	7'-0"	W2	5'-0"	3'-0"
D3	4'-0"	7'-0"	W3	6'-0"	4'-0"
D4	3'-0"	7'-0"	W4	3'-0"	5'-0"
D5			W5	6'-0"	6'-0"
D6			W6	3'-0"	8'-0"
D7					
D8					
D9					

Client:

GOVERNMENT OF THE PUNJAB
PRIMARY & SECONDARY
HEALTHCARE DEPARTMENT

Project:

CAD MAPPING OF TEHSIL
HEAD QUARTER HOSPITALS,
PUNJAB

Consultant:

SKAFS CONSULTANT (Pvt.) Limited
ENGINEERING AND ENVIRONMENT CONSULTANT


Drawing Title:

THQ KOTLI SATTIAN
HOSPITAL MASTER PLAN

Authorized By: SKAFS	Reviewed By Co-Team Leader	Scale: 1:400
Prepared By: CAD TEAMS	Date: FEB, 2017	
Drawing No. SKAFS/KOTLISATTIAN/03		

MASTER PLAN OF THQ HOSPITAL KOTLI SATTIAN

PART 1

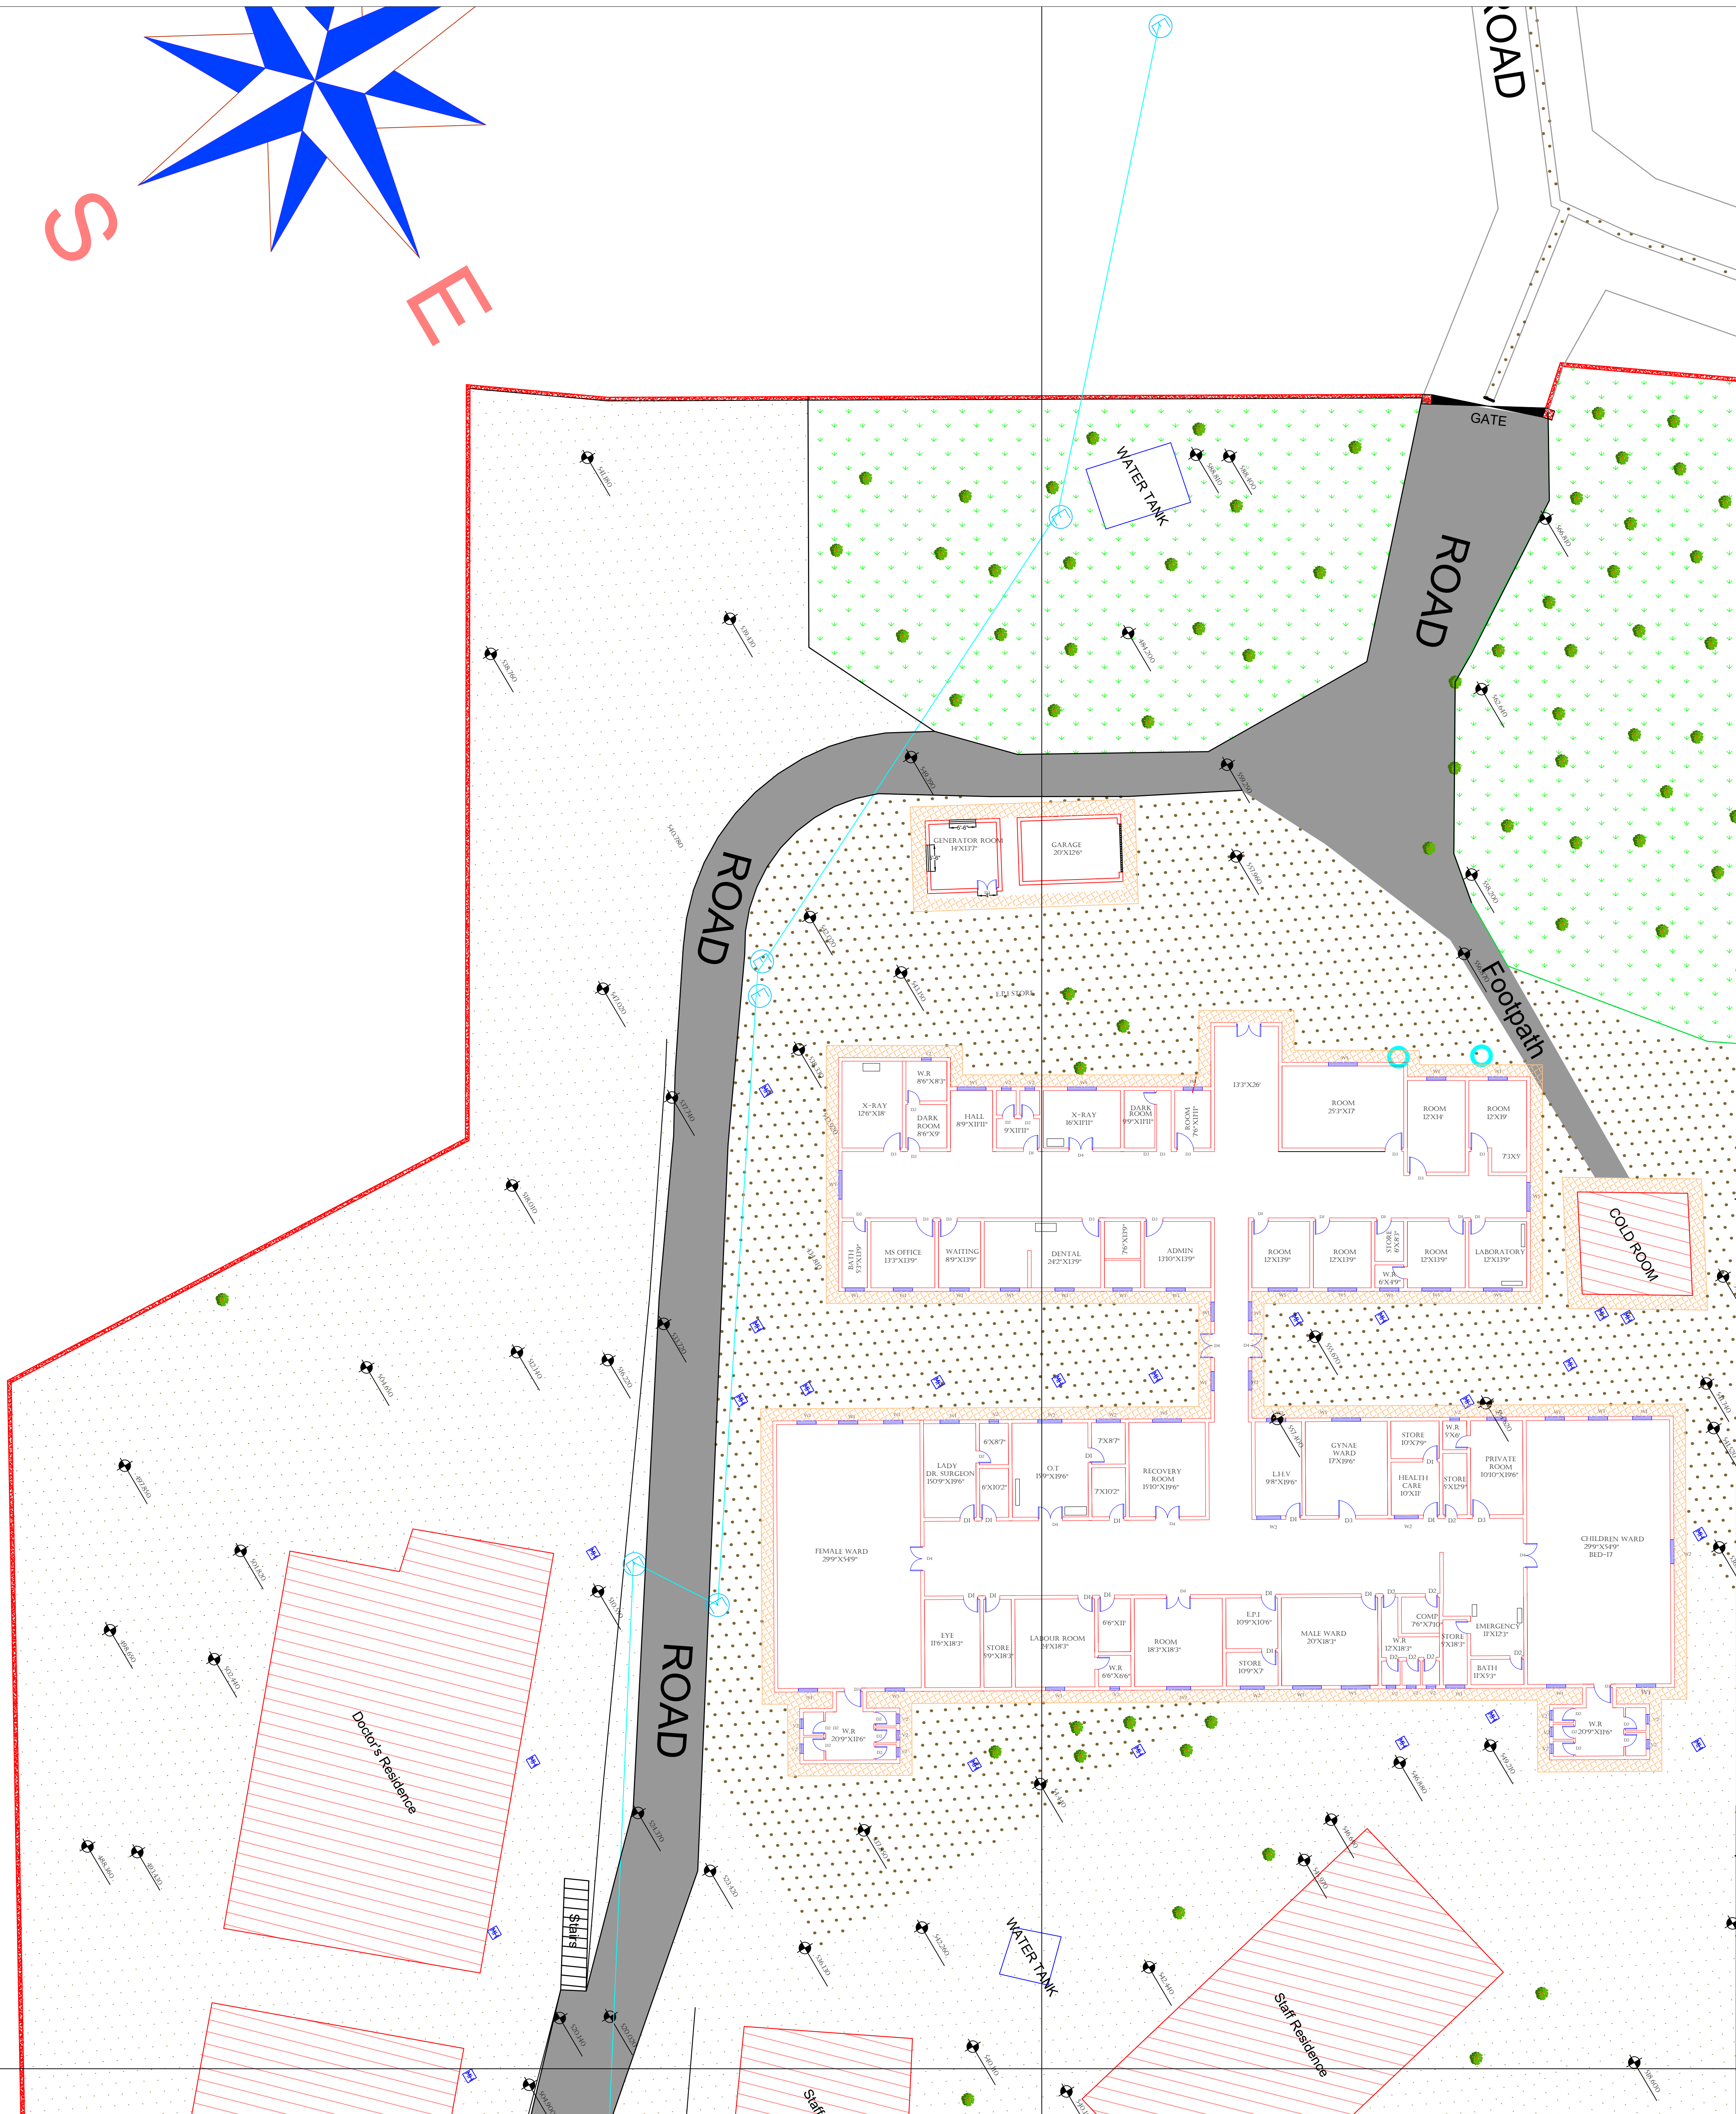

Legends:

RESIDENTIAL AREA	
ROAD	
WALL	
POWER LINE	
OHT	
TREE	
MANHOLE	
TUBE WELL	
LIGHT POLE	
LAWNS	
EARTHEN AREAS	
ASPHALTS ROADS	
TOUGH PAVERS	
P.C.C /PLINTH PROTECTION	
BOUNDARY WALL	
TAP	
HAND PUMP	
BRICK PAVERS	
AIR CONDITIONER	
TUBE LIGHT	
FAN	
ROOF LIGHT	
BULB	

AREA	
AREA WITHIN BOUNDARY WALL	292181.07 SFT
AREA OF CLINICAL BLOCK	22149.16 SFT
PLINTH AREA OF BLOCK	SFT

OPENING SCHEDULE OF DOORS AND WINDOWS					
DOORS	WIDTH	HEIGHT	WINDOWS	WIDTH	HEIGHT
D1	3'-6"	7'-0"	W1	4'-0"	2'-6"
D2	2'-6"	7'-0"	W2	5'-0"	3'-0"
D3	4'-0"	7'-0"	W3	6'-0"	4'-0"
D4	3'-0"	7'-0"	W4	3'-0"	5'-0"
D5			W5	6'-0"	6'-0"
D6			W6	3'-0"	8'-0"
D7					
D8					
D9					

Client:



GOVERNMENT OF THE PUNJAB
PRIMARY & SECONDARY
HEALTHCARE DEPARTMENT

Project:

CAD MAPPING OF TEHSIL
HEAD QUARTER HOSPITALS,
PUNJAB

Consultant:



SKAFS CONSULTANT (Pvt.) Limited
ENGINEERING AND ENVIRONMENT CONSULTANT

Drawing Title:

THQ KOTLI SATTIAN
HOSPITAL MASTER PLAN
PART 1

Authorized By: SKAFS	Reviewed By Co-Team Leader	Scale:
Prepared By: CAD TEAMS	Date: FEB, 2017	Sheet:

Drawing No. SKAFS/KOTLISATTIAN/04

The site plan illustrates the layout of a health facility. A road runs along the left and top boundaries, featuring a gate at the top. A water tank is situated near the gate. The central building complex includes a waiting area, examination rooms, a laboratory, and various wards. A large area of green vegetation is located on the right side. A compass rose in the top left corner indicates the cardinal directions: North (N), South (S), East (E), and West (W).

AREA	
AREA WITHIN BOUNDARY WALL	292181.07 SFT
AREA OF CLINICAL BLOCK	22149.16 SFT
PLINTH AREA OF BLOCK	SFT

Client:



**GOVERNMENT OF THE PUNJAB
PRIMARY & SECONDARY
HEALTHCARE DEPARTMENT**

Consultant:


SKAFS
Sustainable Knowledge And Financial Services

SKAFS CONSULTANT (Pvt.) Limited
ENGINEERING AND ENVIRONMENT CONSULTANT

Authorized By: SKAFS	Reviewed By Co-Team Leader	Scale:
Prepared By:	Date:	Sheet:

Drawing No.	SKAFS/KOTLISATTIAN/05
-------------	------------------------------

MASTER PLAN OF THQ HOSPITAL KOTLI SATTIAN

PART 3



Legends:

RESIDENTIAL AREA	
ROAD	
WALL	
POWER LINE	
OHT	
TREE	
MANHOLE	
TUBE WELL	
LIGHT POLE	
LAWNS	
EARTHEN AREAS	
ASPHALTS ROADS	
TOUGH PAVERS	
P.C.C /PLINTH PROTECTION	
BOUNDARY WALL	
TAP	
HAND PUMP	
BRICK PAVERS	
AIR CONDITIONER	
TUBE LIGHT	
FAN	
ROOF LIGHT	
BULB	

AREA	
AREA WITHIN BOUNDARY WALL	292181.07 SFT
AREA OF CLINICAL BLOCK	22149.16 SFT
PLINTH AREA OF BLOCK	SFT

OPENING SCHEDULE OF DOORS AND WINDOWS					
DOORS	WIDTH	HEIGHT	WINDOWS	WIDTH	HEIGHT
D1	3'-6"	7'-0"	W1	4'-0"	2'-6"
D2	2'-6"	7'-0"	W2	5'-0"	3'-0"
D3	4'-0"	7'-0"	W3	6'-0"	4'-0"
D4	3'-0"	7'-0"	W4	3'-0"	5'-0"
D5			W5	6'-0"	6'-0"
D6			W6	3'-0"	8'-0"
D7					
D8					
D9					

Client:



GOVERNMENT OF THE PUNJAB
PRIMARY & SECONDARY
HEALTHCARE DEPARTMENT

Project:

CAD MAPPING OF TEHSIL
HEAD QUARTER HOSPITALS,
PUNJAB

Consultant:



SKAFS CONSULTANT (Pvt.) Limited
ENGINEERING AND ENVIRONMENT CONSULTANT


Drawing Title:

THQ KOTLI SATTIAN
HOSPITAL MASTER PLAN
PART 3

Authorized By: SKAFS	Reviewed By Co-Team Leader	Scale:
Prepared By: CAD TEAMS	Date: FEB, 2017	
Drawing No.		SKAFS/KOTLISATTIAN /06

MASTER PLAN OF THQ HOSPITAL KOTLI SATTIAN

PART 4

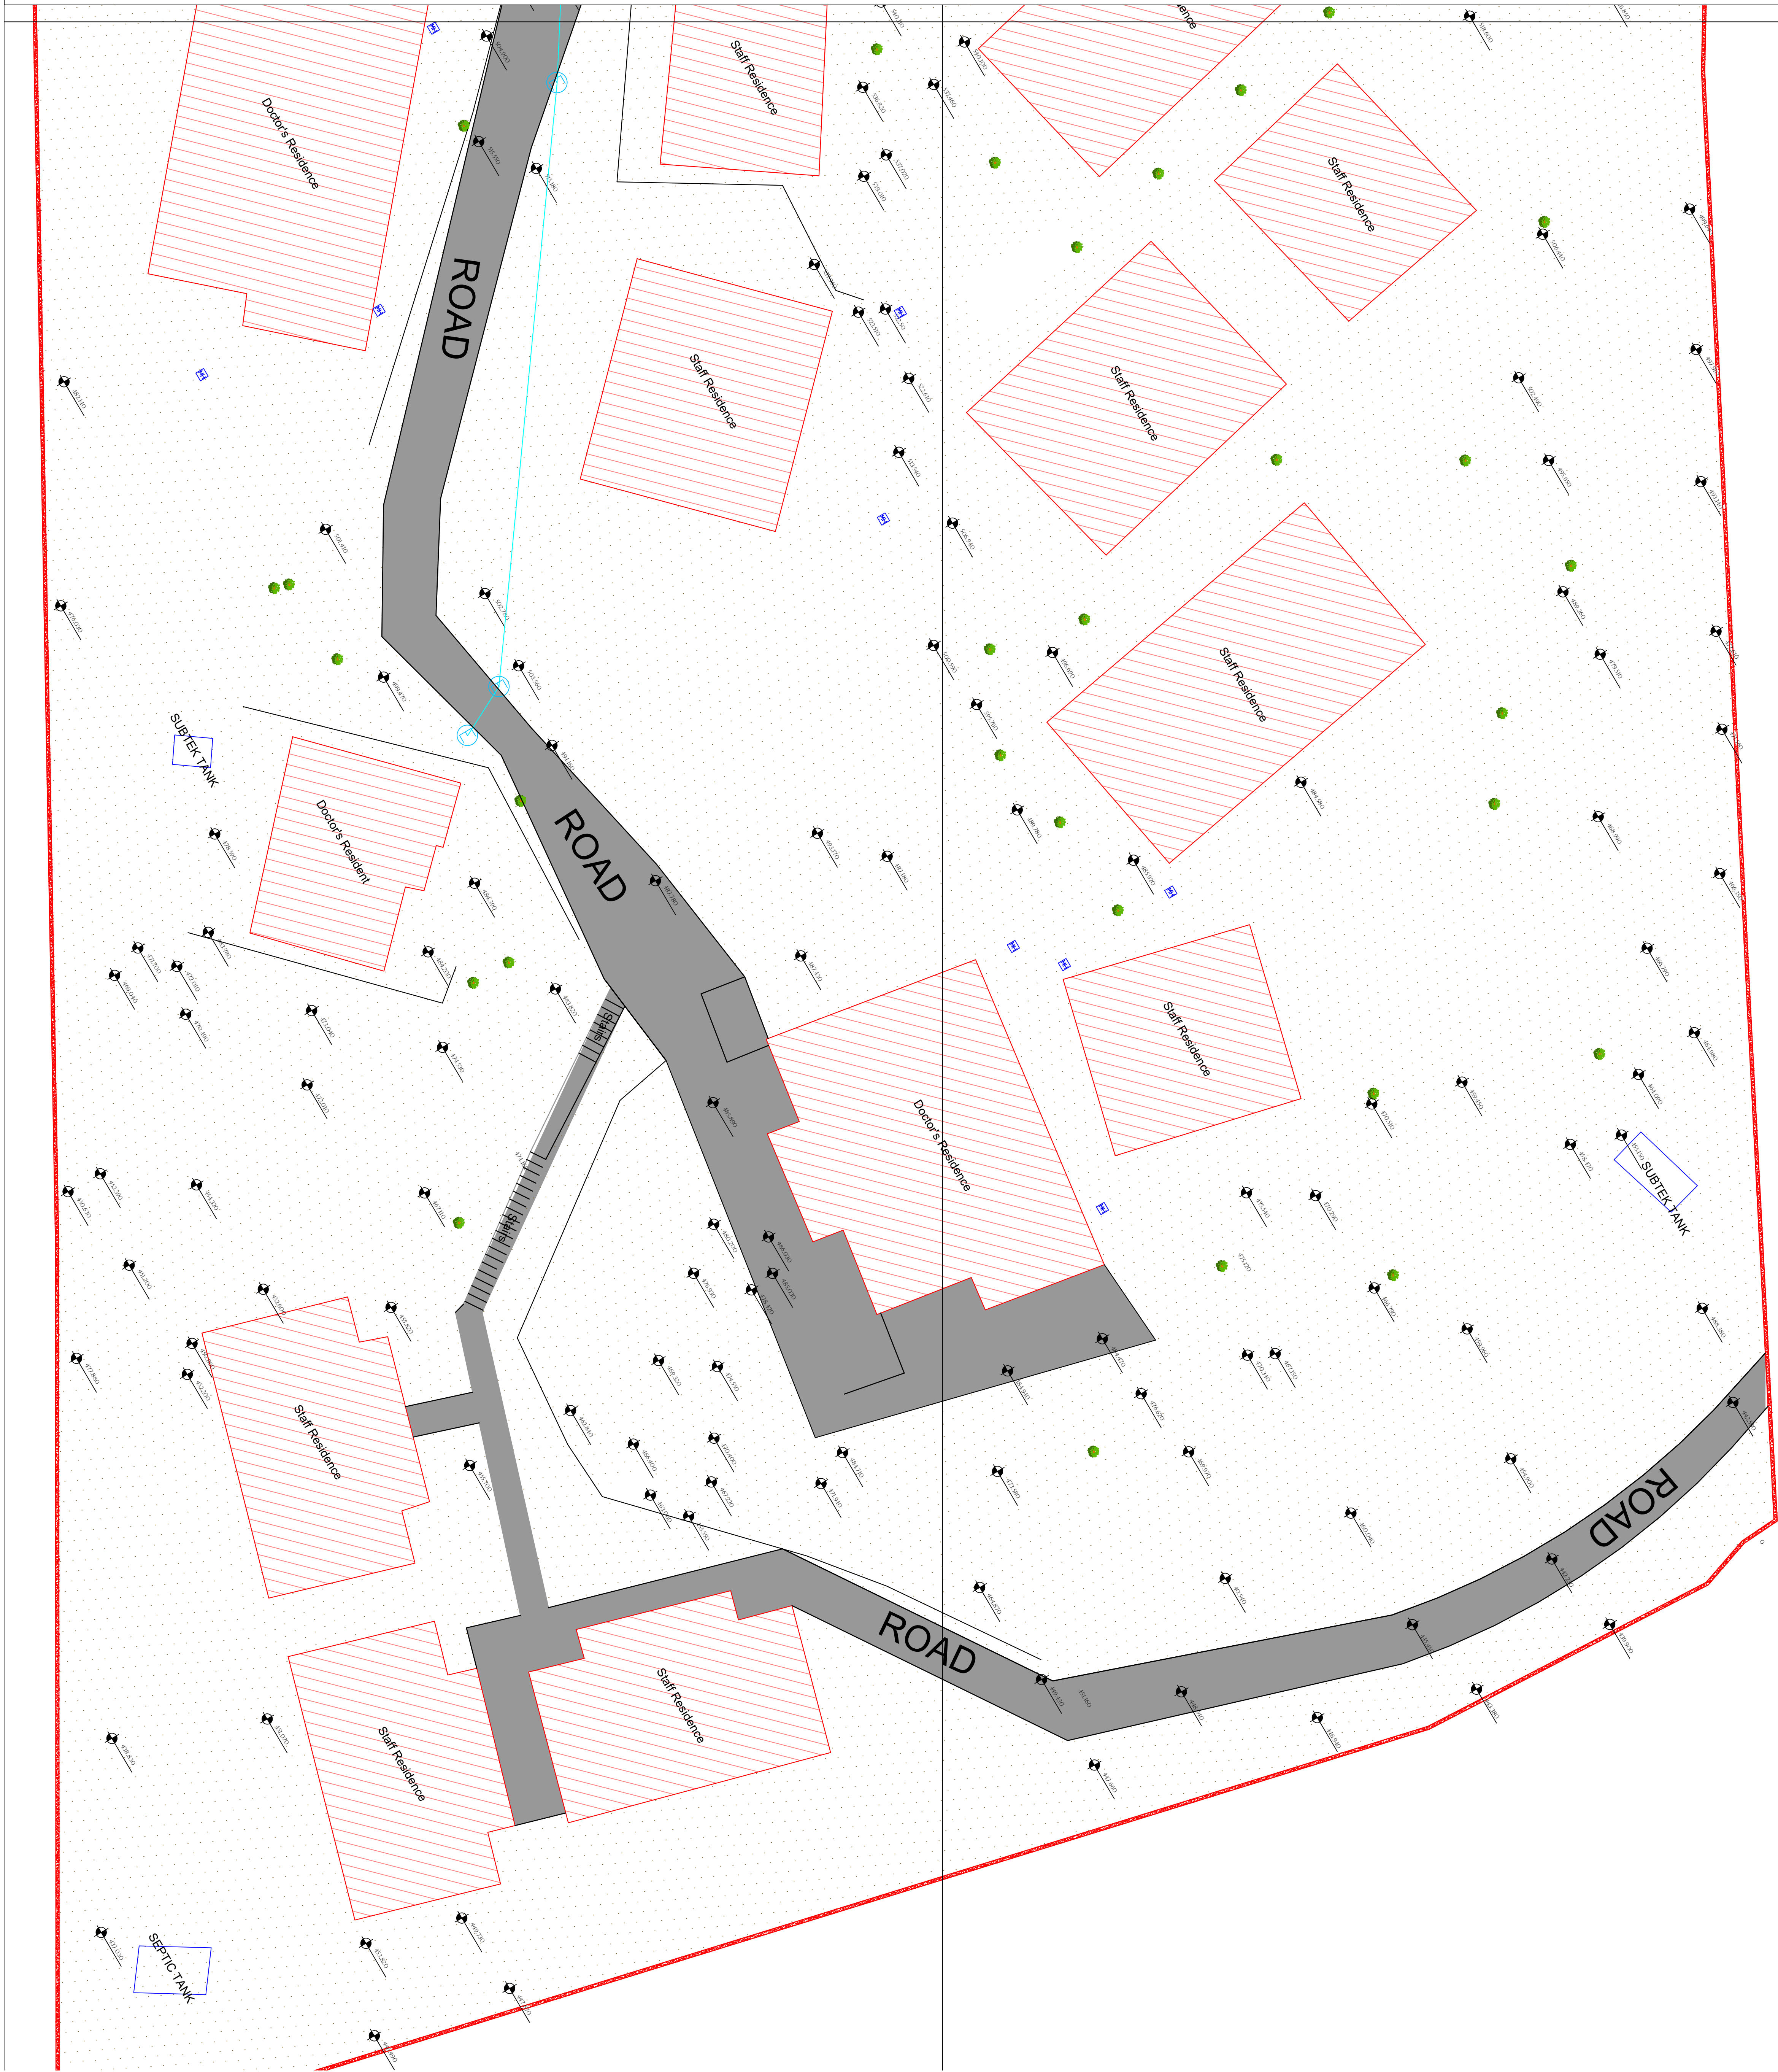

Legends:

RESIDENTIAL AREA	
ROAD	
WALL	
POWER LINE	
OHT	
TREE	
MANHOLE	
TUBE WELL	
LIGHT POLE	
LAWNS	
EARTHEN AREAS	
ASPHALTS ROADS	
TOUGH PAVERS	
P.C.C /PLINTH PROTECTION	
BOUNDARY WALL	
TAP	
HAND PUMP	
BRICK PAVERS	
AIR CONDITIONER	
TUBE LIGHT	
FAN	
ROOF LIGHT	
BULB	

AREA	
AREA WITHIN BOUNDARY WALL	292181.07 SFT
AREA OF CLINICAL BLOCK	22149.16 SFT
PLINTH AREA OF BLOCK	SFT

OPENING SCHEDULE OF DOORS AND WINDOWS					
DOORS	WIDTH	HEIGHT	WINDOWS	WIDTH	HEIGHT
D1	3'-6"	7'-0"	W1	4'-0"	2'-6"
D2	2'-6"	7'-0"	W2	5'-0"	3'-0"
D3	4'-0"	7'-0"	W3	6'-0"	4'-0"
D4	3'-0"	7'-0"	W4	3'-0"	5'-0"
D5			W5	6'-0"	6'-0"
D6			W6	3'-0"	8'-0"
D7					
D8					
D9					

Client:

GOVERNMENT OF THE PUNJAB
PRIMARY & SECONDARY
HEALTHCARE DEPARTMENT

Project:

CAD MAPPING OF TEHSIL
HEAD QUARTER HOSPITALS,
PUNJAB

Consultant:

SKAFS CONSULTANT (Pvt.) Limited
ENGINEERING AND ENVIRONMENT CONSULTANT

Drawing Title:

THQ KOTLI SATTIAN
HOSPITAL MASTER PLAN
PART 4

Authorized By: SKAFS	Reviewed By Co-Team Leader	Scale:
Prepared By: CAD TEAMS	Date: FEB, 2017	

Drawing No.

SKAFS/KOTLISATTIAN /07

CLINICAL BLOCK OF THQ HOSPITAL KOTLI SATTIAN


GROUND FLOOR

PART 1

PART 2

PART 3

PART 4

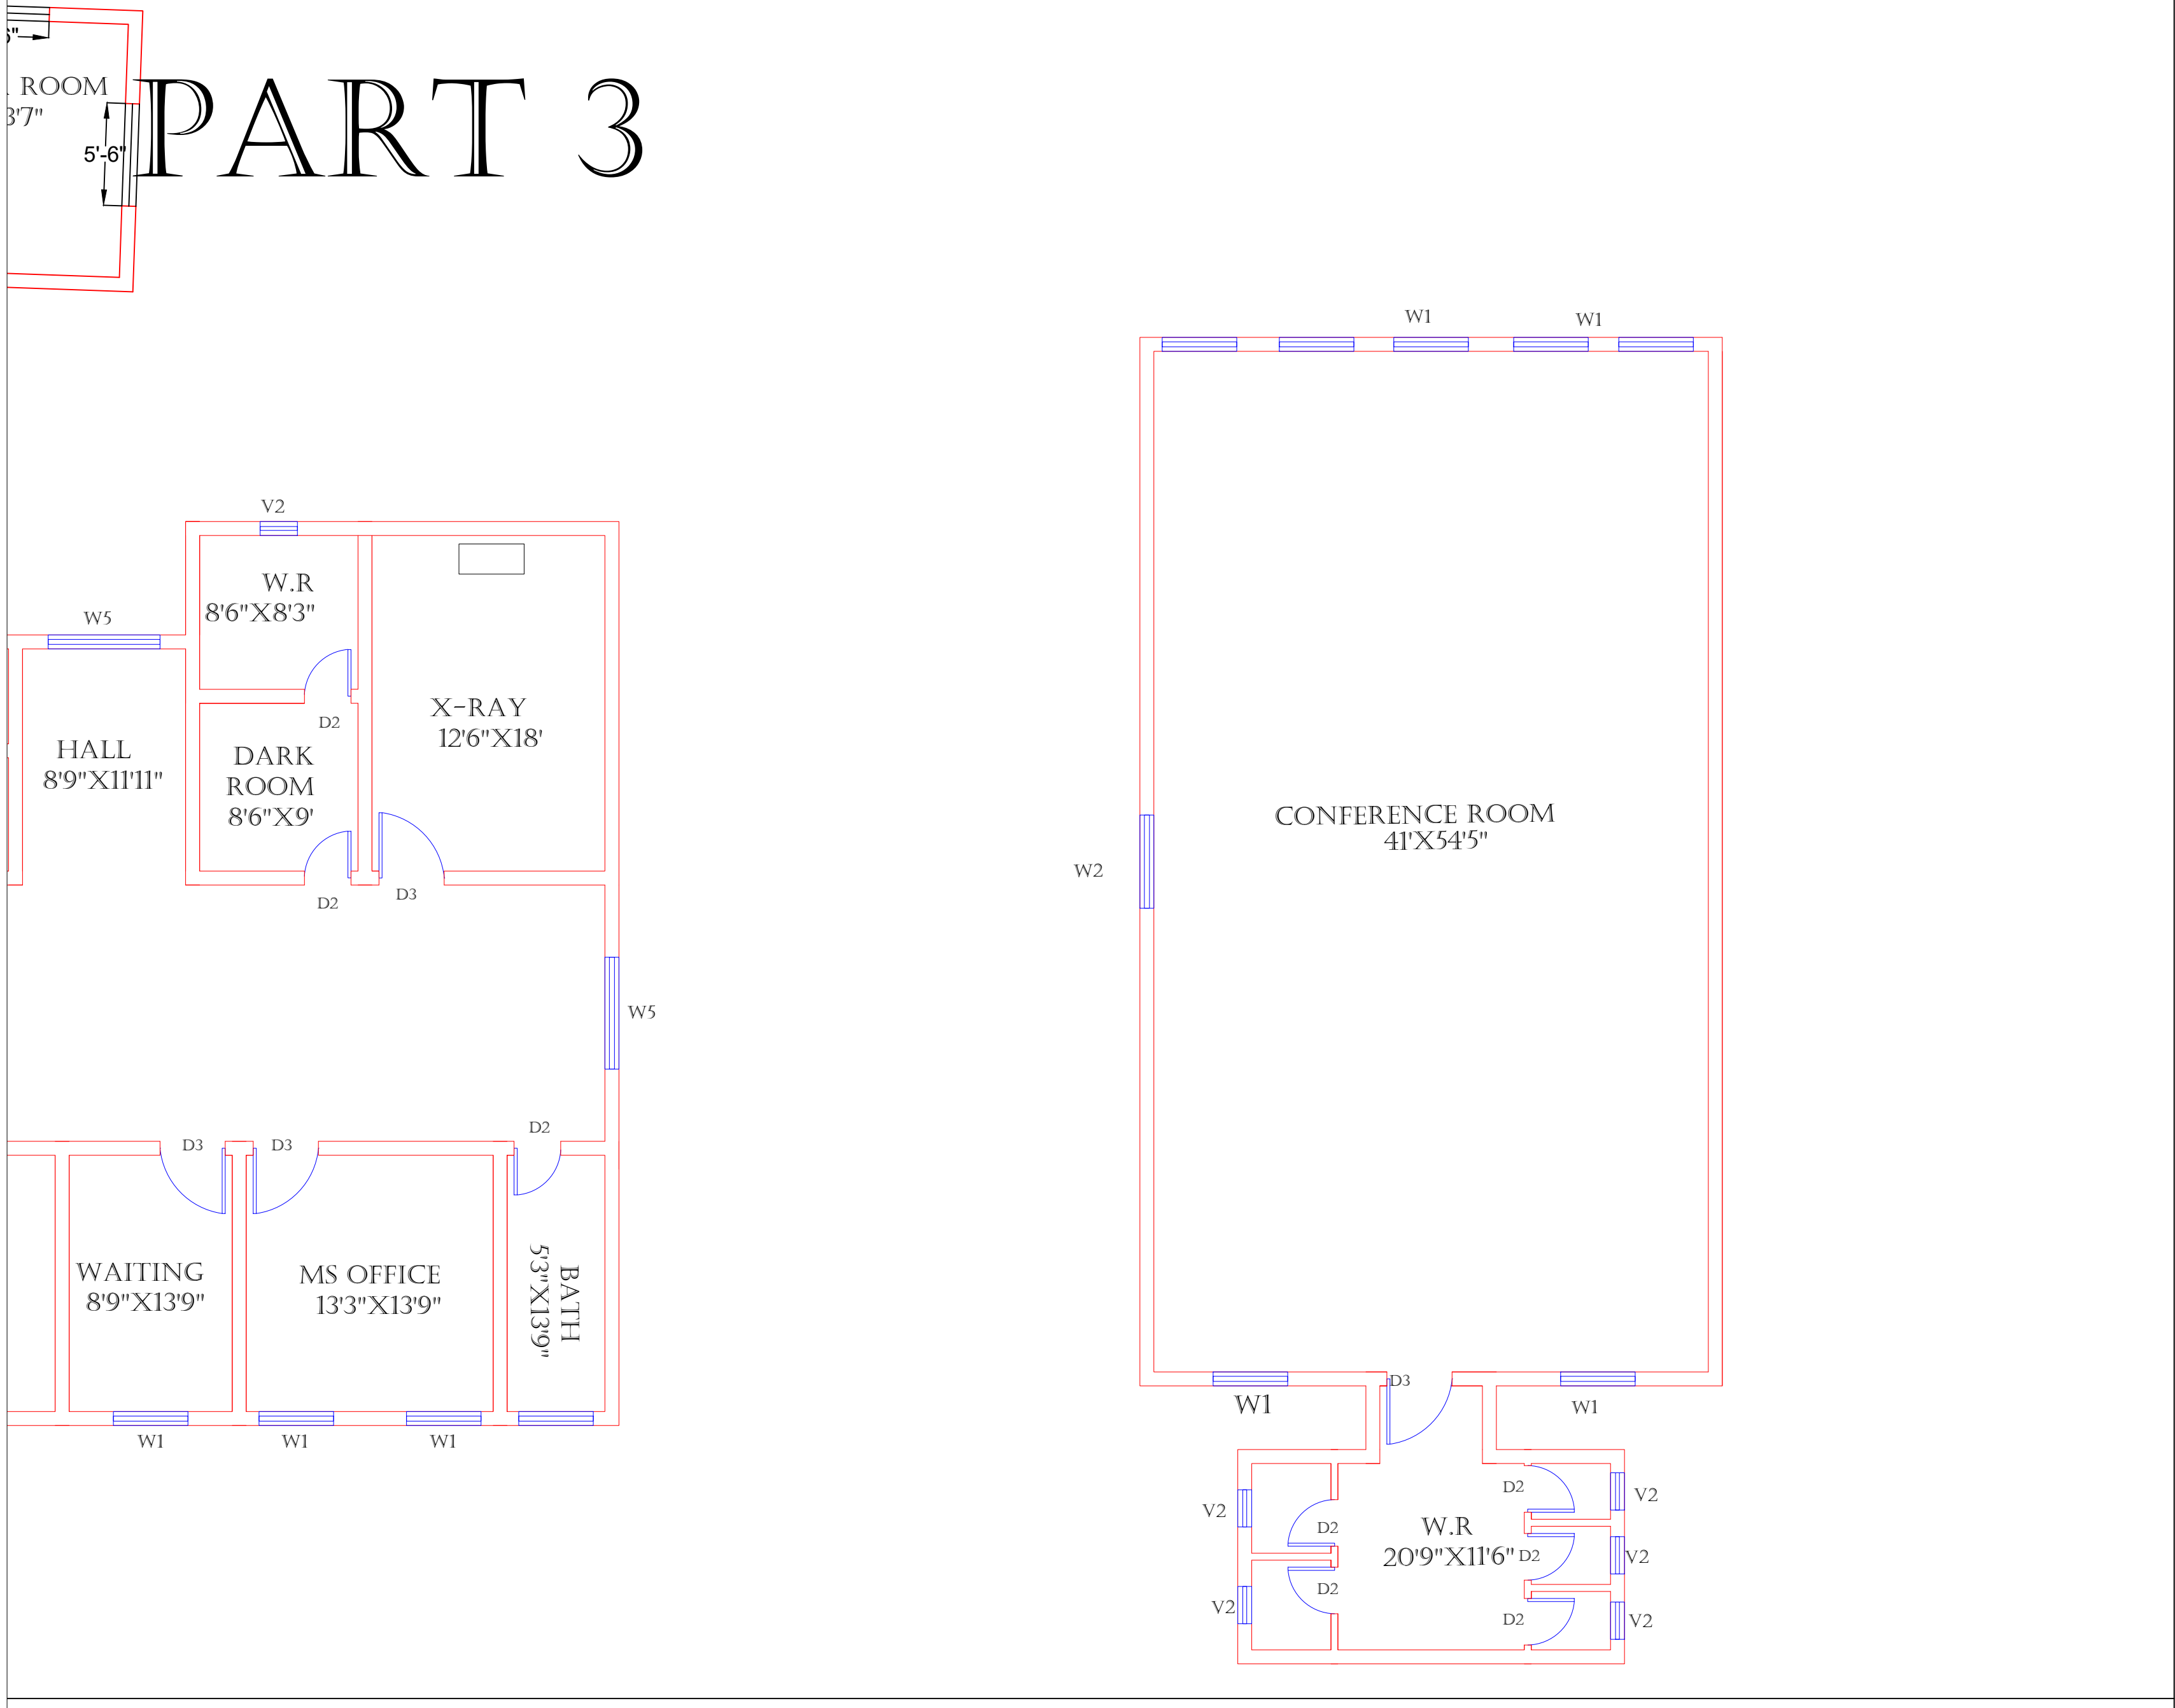

Legends:

RESIDENTIAL AREA	
ROAD	
WALL	
POWER LINE	
OHT	
TREE	
MANHOLE	
TUBE WELL	
LIGHT POLE	
LAWNS	
EARTHEN AREAS	
ASPHALTS ROADS	
TOUGH PAVERS	
P.C.C /PLINTH PROTECTION	
BOUNDARY WALL	
TAP	
HAND PUMP	
BRICK PAVERS	
AIR CONDITIONER	
TUBE LIGHT	
FAN	
ROOF LIGHT	
BULB	

AREA	
AREA WITHIN BOUNDARY WALL	292181.07 SFT
AREA OF CLINICAL BLOCK	22149.16 SFT
PLINTH AREA OF BLOCK	SFT

OPENING SCHEDULE OF DOORS AND WINDOWS					
DOORS	WIDTH	HEIGHT	WINDOWS	WIDTH	HEIGHT
D1	3'-6"	7'-0"	W1	4'-0"	2'-6"
D2	2'-6"	7'-0"	W2	5'-0"	3'-0"
D3	4'-0"	7'-0"	W3	6'-0"	4'-0"
D4	3'-0"	7'-0"	W4	3'-0"	5'-0"
D5			W5	6'-0"	6'-0"
D6			W6	3'-0"	8'-0"
D7					
D8					
D9					

Client:


GOVERNMENT OF THE PUNJAB
PRIMARY & SECONDARY
HEALTHCARE DEPARTMENT

Project:

CAD MAPPING OF TEHSIL
HEAD QUARTER HOSPITALS,
PUNJAB

Consultant:


SKAFS CONSULTANT (Pvt.) Limited
ENGINEERING AND ENVIRONMENT CONSULTANT

Drawing Title:

THQ KOTLI SATTIAN
HOSPITAL MAIN BUILDING
CLINICAL BLOCK PLAN

Authorized By: SKAFS	Reviewed By Co-Team Leader	Scale: 1:400
Prepared By: CAD TEAMS	Date: FEB, 2017	
Drawing No. SKAFS/KOTLISATTIAN/08		

CLINICAL BLOCK OF THQ HOSPITAL KOTLI SATTIAN

GROUND FLOOR (PART 1)

Legends:

RESIDENTIAL AREA	
ROAD	
WALL	
POWER LINE	
OHT	
TREE	
MANHOLE	
TUBE WELL	
LIGHT POLE	
LAWNS	
EARTHEN AREAS	
ASPHALTS ROADS	
TOUGH PAVERS	
P.C.C /PLINTH PROTECTION	
BOUNDARY WALL	
TAP	
HAND PUMP	
BRICK PAVERS	
AIR CONDITIONER	
TUBE LIGHT	
FAN	
ROOF LIGHT	
BULB	

AREA	
AREA WITHIN BOUNDARY WALL	292181.07 SFT
AREA OF CLINICAL BLOCK	22149.16 SFT
PLINTH AREA OF BLOCK	SFT

OPENING SCHEDULE OF DOORS AND WINDOWS					
DOORS	WIDTH	HEIGHT	WINDOWS	WIDTH	HEIGHT
D1	3'-6"	7'-0"	W1	4'-0"	2'-6"
D2	2'-6"	7'-0"	W2	5'-0"	3'-0"
D3	4'-0"	7'-0"	W3	6'-0"	4'-0"
D4	3'-0"	7'-0"	W4	3'-0"	5'-0"
D5			W5	6'-0"	6'-0"
D6			W6	3'-0"	8'-0"
D7					
D8					
D9					

Client:



GOVERNMENT OF THE PUNJAB
PRIMARY & SECONDARY
HEALTHCARE DEPARTMENT

Project:

CAD MAPPING OF TEHSIL
HEAD QUARTER HOSPITALS,
PUNJAB

Consultant:



SKAFS CONSULTANT (Pvt.) Limited
ENGINEERING AND ENVIRONMENT CONSULTANT

Drawing Title:

THQ KOTLI SATTIAN
HOSPITAL CLINICAL BLOCK
PART 1

Authorized By: SKAFS	Reviewed By Co-Team Leader	Scale:
Prepared By: CAD TEAMS	Date: FEB, 2017	

Drawing No.

SKAFS/KOTLISATTIAN /09



CLINICAL BLOCK OF THQ HOSPITAL KOTLI SATTIAN

GROUND FLOOR (PART 2)

Legends:

RESIDENTIAL AREA	
ROAD	
WALL	
POWER LINE	
OHT	
TREE	
MANHOLE	
TUBE WELL	
LIGHT POLE	
LAWNS	
EARTHEN AREAS	
ASPHALTS ROADS	
TOUGH PAVERS	
P.C.C /PLINTH PROTECTION	
BOUNDARY WALL	
TAP	
HAND PUMP	
BRICK PAVERS	
AIR CONDITIONER	
TUBE LIGHT	
FAN	
ROOF LIGHT	
BULB	

AREA	
AREA WITHIN BOUNDARY WALL	292181.07 SFT
AREA OF CLINICAL BLOCK	22149.16 SFT
PLINTH AREA OF BLOCK	SFT

OPENING SCHEDULE OF DOORS AND WINDOWS					
DOORS	WIDTH	HEIGHT	WINDOWS	WIDTH	HEIGHT
D1	3'-6"	7'-0"	W1	4'-0"	2'-6"
D2	2'-6"	7'-0"	W2	5'-0"	3'-0"
D3	4'-0"	7'-0"	W3	6'-0"	4'-0"
D4	3'-0"	7'-0"	W4	3'-0"	5'-0"
D5			W5	6'-0"	6'-0"
D6			W6	3'-0"	8'-0"
D7					
D8					
D9					

Client:



GOVERNMENT OF THE PUNJAB
PRIMARY & SECONDARY
HEALTHCARE DEPARTMENT

Project:

CAD MAPPING OF TEHSIL
HEAD QUARTER HOSPITALS,
PUNJAB

Consultant:



SKAFS CONSULTANT (Pvt.) Limited
ENGINEERING AND ENVIRONMENT CONSULTANT

Drawing Title:

THQ KOTLI SATTIAN
HOSPITAL CLINICAL BLOCK
PART 2

Authorized By: SKAFS	Reviewed By Co-Team Leader	Scale:
Prepared By: CAD TEAMS	Date: FEB, 2017	

Drawing No.

SKAFS/KOTLISATTIAN /10

ROOM

5'-6"

W5

HALL
8'9"X11'11"

W.R.
8'6"X8'3"

D2

DARK ROOM
8'6"X9'

D2

X-RAY
12'6"X18'

D3

D3

D3

D3

D2

WAITING
8'9"X13'9"


MS OFFICE
13'3"X13'9"

BATH
5'3"X13'9"

W1

W1

W1

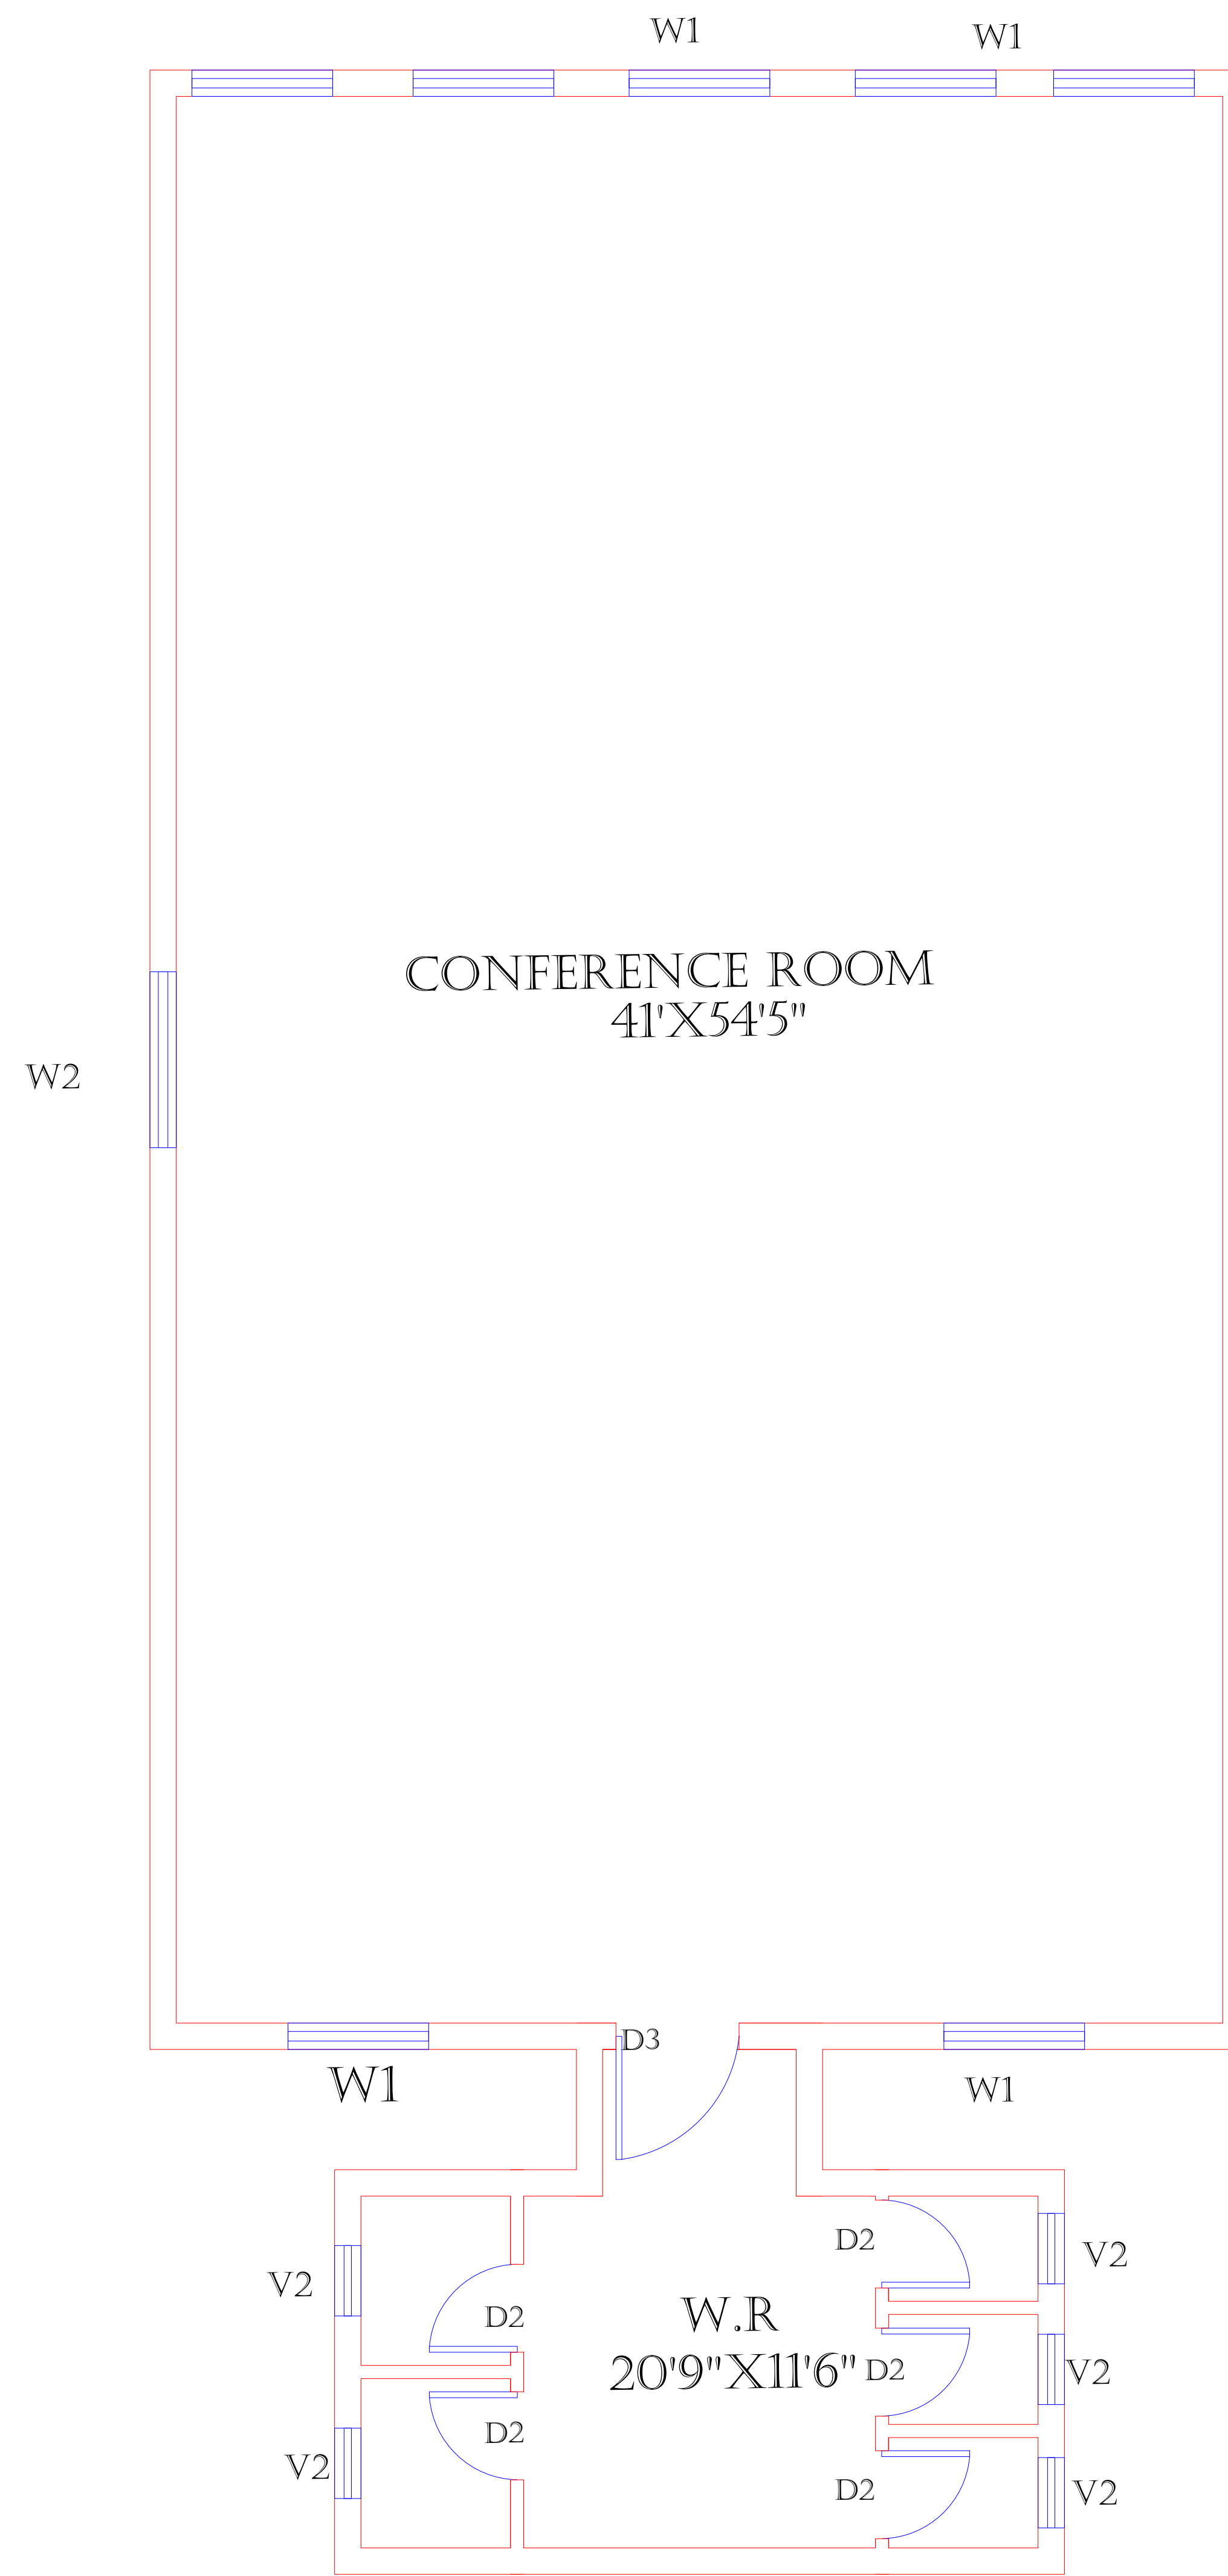

Legends:	
RESIDENTIAL AREA	
ROAD	
WALL	
POWER LINE	
OHT	
TREE	
MANHOLE	
TUBE WELL	
LIGHT POLE	
LAWNS	
EARTHEN AREAS	
ASPHALTS ROADS	
TOUGH PAVERS	
P.C.C /PLINTH PROTECTION	
BOUNDARY WALL	
TAP	
HAND PUMP	
BRICK PAVERS	
AIR CONDITIONER	
TUBE LIGHT	
FAN	
ROOF LIGHT	
BULB	

AREA	
AREA WITHIN BOUNDARY WALL	292181.07 SFT
AREA OF CLINICAL BLOCK	22149.16 SFT
PLINTH AREA OF BLOCK	SFT

OPENING SCHEDULE OF DOORS AND WINDOWS					
DOORS	WIDTH	HEIGHT	WINDOWS	WIDTH	HEIGHT
D1	3'-6"	7'-0"	W1	4'-0"	2'-6"
D2	2'-6"	7'-0"	W2	5'-0"	3'-0"
D3	4'-0"	7'-0"	W3	6'-0"	4'-0"
D4	3'-0"	7'-0"	W4	3'-0"	5'-0"
D5			W5	6'-0"	6'-0"
D6			W6	3'-0"	8'-0"
D7					
D8					
D9					

Client:



**GOVERNMENT OF THE PUNJAB
PRIMARY & SECONDARY
HEALTHCARE DEPARTMENT**

Project:

CAD MAPPING OF TEHSIL HEAD QUARTER HOSPITALS, PUNJAB

Consultant:



SKAFS CONSULTANT (Pvt.) Limited
ENGINEERING AND ENVIRONMENT CONSULTANT

Drawing Title: **THQ KOTLI SATTIAN
HOSPITAL CLINICAL BLOCK
PART 3**

Authorized By: SKAFS	Reviewed By Co-Team Leader	Scale:
Prepared By: CAD TEAMS	Date: FEB, 2017	

Drawing No. **SKAFS/KOTLISATTIAN /11**

CLINICAL BLOCK OF THQ HOSPITAL KOTLI SATTIAN

GROUND FLOOR (PART 4)

Legends:

RESIDENTIAL AREA	
ROAD	
WALL	
POWER LINE	
OHT	
TREE	
MANHOLE	
TUBE WELL	
LIGHT POLE	
LAWNS	
EARTHEN AREAS	
ASPHALTS ROADS	
TOUGH PAVERS	
P.C.C /PLINTH PROTECTION	
BOUNDARY WALL	
TAP	
HAND PUMP	
BRICK PAVERS	
AIR CONDITIONER	
TUBE LIGHT	
FAN	
ROOF LIGHT	
BULB	

AREA	
AREA WITHIN BOUNDARY WALL	292181.07 SFT
AREA OF CLINICAL BLOCK	22149.16 SFT
PLINTH AREA OF BLOCK	SFT

OPENING SCHEDULE OF DOORS AND WINDOWS					
DOORS	WIDTH	HEIGHT	WINDOWS	WIDTH	HEIGHT
D1	3'-6"	7'-0"	W1	4'-0"	2'-6"
D2	2'-6"	7'-0"	W2	5'-0"	3'-0"
D3	4'-0"	7'-0"	W3	6'-0"	4'-0"
D4	3'-0"	7'-0"	W4	3'-0"	5'-0"
D5			W5	6'-0"	6'-0"
D6			W6	3'-0"	8'-0"
D7					
D8					
D9					

Client:



GOVERNMENT OF THE PUNJAB
PRIMARY & SECONDARY
HEALTHCARE DEPARTMENT

Project:

CAD MAPPING OF TEHSIL
HEAD QUARTER HOSPITALS,
PUNJAB

Consultant:



SKAFS CONSULTANT (Pvt.) Limited
ENGINEERING AND ENVIRONMENT CONSULTANT

Drawing Title:

THQ KOTLI SATTIAN
HOSPITAL CLINICAL BLOCK
PART 4

Authorized By: SKAFS	Reviewed By Co-Team Leader	Scale:
Prepared By: CAD TEAMS	Date: FEB, 2017	

Drawing No.

SKAFS/KOTLISATTIAN /12

ELECTRICAL LAYOUT PLAN OF THQ HOSPITAL KOTLI SATTIAN

GROUND FLOOR

Legends:

RESIDENTIAL AREA	
ROAD	
WALL	
POWER LINE	
OHT	
TREE	
MANHOLE	
TUBE WELL	
LIGHT POLE	
LAWNS	
EARTHEN AREAS	
ASPHALTS ROADS	
TOUGH PAVERS	
P.C.C /PLINTH PROTECTION	
BOUNDARY WALL	
TAP	
HAND PUMP	
BRICK PAVERS	
AIR CONDITIONER	
TUBE LIGHT	
FAN	
ROOF LIGHT	
BULB	

AREA	
AREA WITHIN BOUNDARY WALL	292181.07 SFT
AREA OF CLINICAL BLOCK	22149.16 SFT
PLINTH AREA OF BLOCK	SFT

OPENING SCHEDULE OF DOORS AND WINDOWS					
DOORS	WIDTH	HEIGHT	WINDOWS	WIDTH	HEIGHT
D1	3'-6"	7'-0"	W1	4'-0"	2'-6"
D2	2'-6"	7'-0"	W2	5'-0"	3'-0"
D3	4'-0"	7'-0"	W3	6'-0"	4'-0"
D4	3'-0"	7'-0"	W4	3'-0"	5'-0"
D5			W5	6'-0"	6'-0"
D6			W6	3'-0"	8'-0"
D7					
D8					
D9					

Client:



GOVERNMENT OF THE PUNJAB

PRIMARY & SECONDARY

HEALTHCARE DEPARTMENT

Project:

CAD MAPPING OF TEHSIL

HEAD QUARTER HOSPITALS,

PUNJAB

Consultant:



SKAFS CONSULTANT (Pvt.) Limited

ENGINEERING AND ENVIRONMENT CONSULTANT

Drawing Title:

THQ KOTLI SATTIAN

ELECTRICAL LAYOUT

GROUND FLOOR

Authorized By: SKAFS	Reviewed By Co-Team Leader	Scale:
Prepared By: CAD TEAMS	Date: FEB, 2017	

