


MASTER PLAN OF THQ HOSPITAL NOWSHERA VIRKAN

PART 1

PART 2

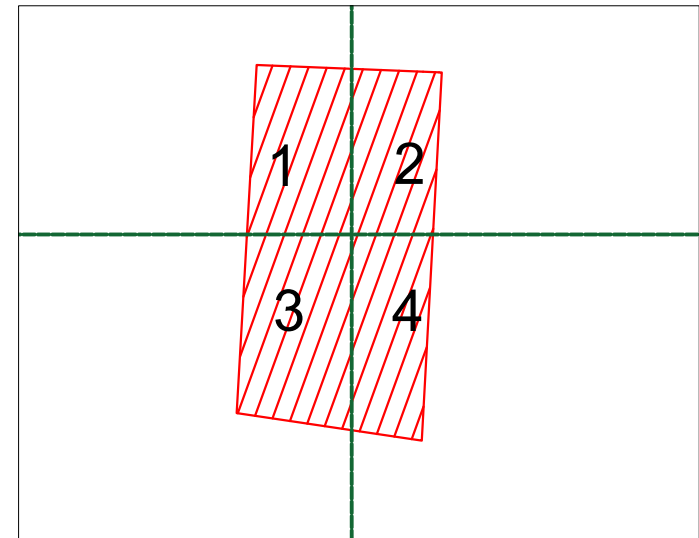

PART 3

PART 4

Legends:

|                           |  |
|---------------------------|--|
| Residential Area          |  |
| Road                      |  |
| Wall                      |  |
| Power Line                |  |
| OHT                       |  |
| Tree                      |  |
| Man Hole                  |  |
| Tube Well                 |  |
| Light Pole                |  |
| Lawns                     |  |
| Earthen Areas             |  |
| Asphalts Roads            |  |
| Tough Pavers              |  |
| P.C.C / Plinth Protection |  |
| Boundary Wall             |  |
| Brick Pavers / Soling     |  |
| Drain                     |  |
| Tap                       |  |
| Hand Pump                 |  |
| Air Conditioner           |  |
| Tube Light                |  |
| Fan                       |  |
| Roof Light                |  |
| Bulb                      |  |

| AREA                      |              |
|---------------------------|--------------|
| AREA WITHIN BOUNDARY WALL | 97299.94 Sft |
| AREA OF CLINICAL BLOCK    | 21692.06 Sft |
| PLINTH AREA OF BLOCK      | 11681.95 Sft |


| OPENING SCHEDULE OF DOORS AND WINDOWS |       |        |         |       |        |
|---------------------------------------|-------|--------|---------|-------|--------|
| DOORS                                 | WIDTH | HEIGHT | WINDOWS | WIDTH | HEIGHT |
| D2                                    | 2'-6" | 7'-0"  | W1      | 3'-0" | 3'-0"  |
| D3                                    | 3'-0" | 7'-0"  | W2      | 4'-0" | 4'-0"  |
| D4                                    | 3'-6" | 7'-0"  | W3      | 6'-0" | 6'-0"  |
| D5                                    | 4'-0" | 7'-0"  | W4      | 8'-0" | 8'-0"  |
| D6                                    | 4'-6" | 7'-0"  | V1      | 2'-0" | 2'-0"  |
| D7                                    | 5'-0" | 7'-0"  |         |       |        |
|                                       |       |        |         |       |        |
|                                       |       |        |         |       |        |
|                                       |       |        |         |       |        |

Project:  
**CAD MAPPING OF TEHSIL  
HEAD QUARTER HOSPITALS,  
PUNJAB**

|                                                                                         |                                                                                                    |
|-----------------------------------------------------------------------------------------|----------------------------------------------------------------------------------------------------|
| Client:<br><br>GOVERNMENT OF THE PUNJAB<br>PRIMARY & SECONDARY<br>HEALTHCARE DEPARTMENT | Consultant:<br><br>SKAFS CONSULTANT (Pvt.)<br>Limited<br>ENGINEERING AND ENVIRONMENT<br>CONSULTANT |
|-----------------------------------------------------------------------------------------|----------------------------------------------------------------------------------------------------|

Drawing Title:  
**THQ NOWSHERA VIRKAN  
HOSPITAL MASTER PLAN**

Drawing No.  
**SKAFS/NOWSHERA.VK /03**

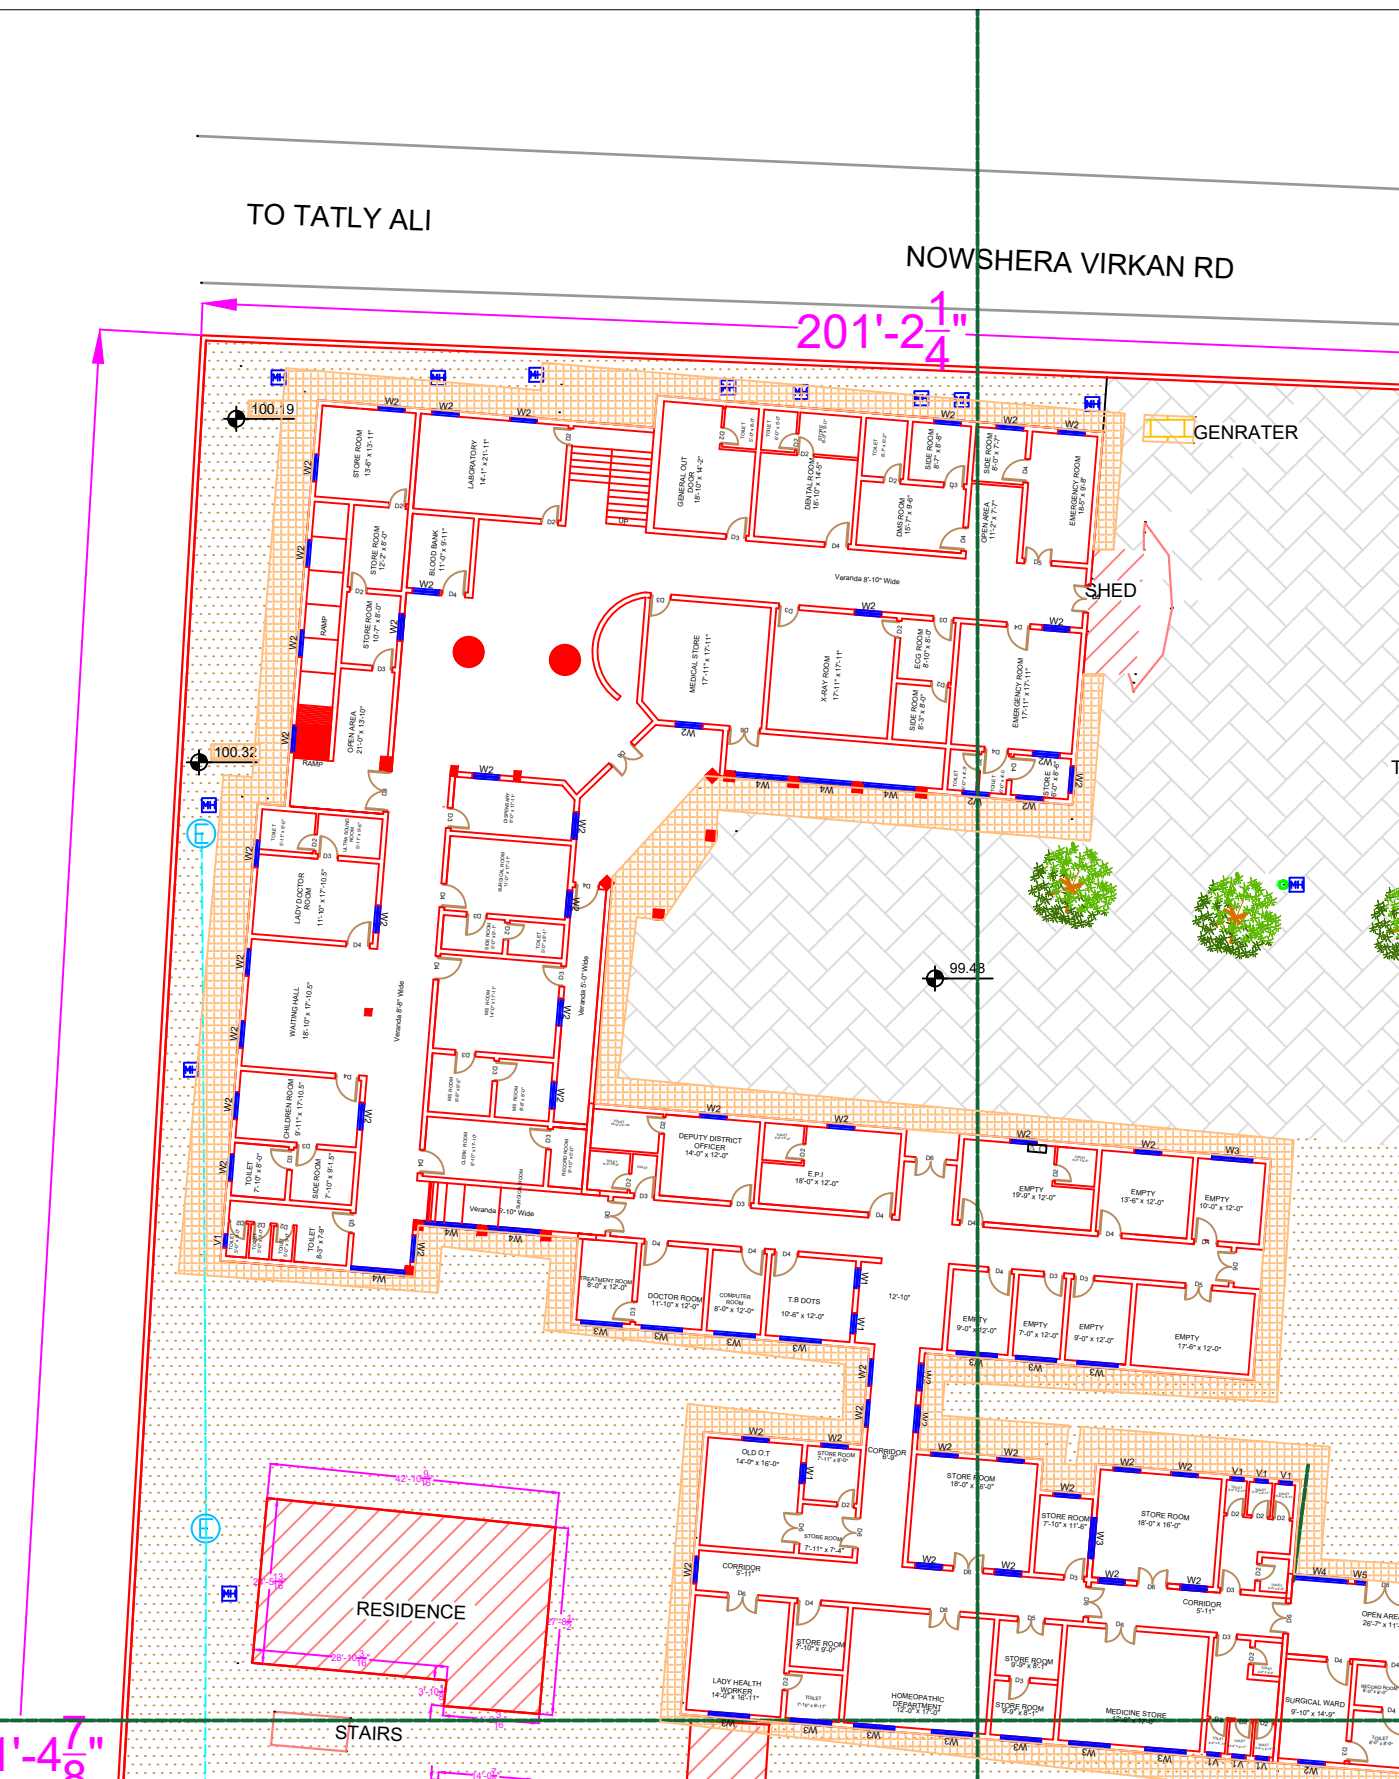

### Legends:

|                           |                                                                                       |
|---------------------------|---------------------------------------------------------------------------------------|
| Residential Area          |    |
| Road                      |    |
| Wall                      |    |
| Power Line                |    |
| OHT                       |    |
| Tree                      |    |
| Man Hole                  |    |
| Tube Well                 |    |
| Light Pole                |    |
| Lawns                     |    |
| Earthen Areas             |    |
| Asphalts Roads            |    |
| Tough Pavers              |    |
| P.C.C / Plinth Protection |    |
| Boundary Wall             |    |
| Brick Pavers / Soling     |    |
| Drain                     |   |
| Tap                       |  |
| Hand Pump                 |  |
| Air Conditioner           |  |
| Tube Light                |  |
| Fan                       |  |
| Roof Light                |  |
| Bulb                      |  |

| AREA                      |              |
|---------------------------|--------------|
| AREA WITHIN BOUNDARY WALL | 97299.94 Sft |
| AREA OF CLINICAL BLOCK    | 21692.06 Sft |
| PLINTH AREA OF BLOCK      | 11681.95 Sft |

| OPENING SCHEDULE OF DOORS AND WINDOWS |       |        |         |       |        |
|---------------------------------------|-------|--------|---------|-------|--------|
| DOORS                                 | WIDTH | HEIGHT | WINDOWS | WIDTH | HEIGHT |
| D2                                    | 2'-6" | 7'-0"  | W1      | 3'-0" | 3'-0"  |
| D3                                    | 3'-0" | 7'-0"  | W2      | 4'-0" | 4'-0"  |
| D4                                    | 3'-6" | 7'-0"  | W3      | 6'-0" | 6'-0"  |
| D5                                    | 4'-0" | 7'-0"  | W4      | 8'-0" | 8'-0"  |
| D6                                    | 4'-6" | 7'-0"  | V1      | 2'-0" | 2'-0"  |
| D7                                    | 5'-0" | 7'-0"  |         |       |        |
|                                       |       |        |         |       |        |
|                                       |       |        |         |       |        |
|                                       |       |        |         |       |        |
|                                       |       |        |         |       |        |

Project:  
**CAD MAPPING OF TEHSIL  
HEAD QUARTER HOSPITALS,  
PUNJAB**


|                                                                                                                                                                                                          |                                                                                                                                                                                                                         |
|----------------------------------------------------------------------------------------------------------------------------------------------------------------------------------------------------------|-------------------------------------------------------------------------------------------------------------------------------------------------------------------------------------------------------------------------|
| <p><b>Client:</b></p>  <p><b>GOVERNMENT OF THE PUNJAB<br/>PRIMARY &amp; SECONDARY<br/>HEALTHCARE DEPARTMENT</b></p> | <p><b>Consultant:</b></p>  <p><b>SKAFS CONSULTANT (Pvt.)<br/>Limited</b><br/><i>ENGINEERING AND ENVIRONMENT<br/>CONSULTANT</i></p> |
|----------------------------------------------------------------------------------------------------------------------------------------------------------------------------------------------------------|-------------------------------------------------------------------------------------------------------------------------------------------------------------------------------------------------------------------------|

Drawing Title:  
**THQ NOWSHERA VIRKAN  
HOSPITAL MASTER PLAN PART 1**

Drawing No. **SKAFS/NOWSHERA.VK /04**

# MASTER PLAN OF THQ HOSPITAL NOWSHERAVIRKAN

## PART 2

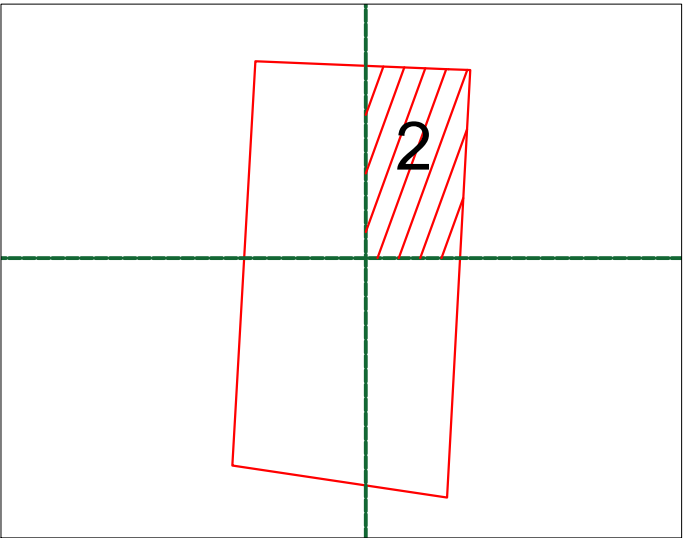

**Legends:**

|                           |  |
|---------------------------|--|
| Residential Area          |  |
| Road                      |  |
| Wall                      |  |
| Power Line                |  |
| OHT                       |  |
| Tree                      |  |
| Man Hole                  |  |
| Tube Well                 |  |
| Light Pole                |  |
| Lawns                     |  |
| Earthen Areas             |  |
| Asphalts Roads            |  |
| Tough Pavers              |  |
| P.C.C / Plinth Protection |  |
| Boundary Wall             |  |
| Brick Pavers / Soling     |  |
| Drain                     |  |
| Tap                       |  |
| Hand Pump                 |  |
| Air Conditioner           |  |
| Tube Light                |  |
| Fan                       |  |
| Roof Light                |  |
| Bulb                      |  |

| AREA                      |  |              |  |  |  |
|---------------------------|--|--------------|--|--|--|
| AREA WITHIN BOUNDARY WALL |  | 97299.94 Sft |  |  |  |
| AREA OF CLINICAL BLOCK    |  | 21692.06 Sft |  |  |  |
| PLINTH AREA OF BLOCK      |  | 11681.95 Sft |  |  |  |

| OPENING SCHEDULE OF DOORS AND WINDOWS |       |        |         |       |        |
|---------------------------------------|-------|--------|---------|-------|--------|
| DOORS                                 | WIDTH | HEIGHT | WINDOWS | WIDTH | HEIGHT |
| D2                                    | 2'-6" | 7'-0"  | W1      | 3'-0" | 3'-0"  |
| D3                                    | 3'-0" | 7'-0"  | W2      | 4'-0" | 4'-0"  |
| D4                                    | 3'-6" | 7'-0"  | W3      | 6'-0" | 6'-0"  |
| D5                                    | 4'-0" | 7'-0"  | W4      | 8'-0" | 8'-0"  |
| D6                                    | 4'-6" | 7'-0"  | V1      | 2'-0" | 2'-0"  |
| D7                                    | 5'-0" | 7'-0"  |         |       |        |
|                                       |       |        |         |       |        |
|                                       |       |        |         |       |        |
|                                       |       |        |         |       |        |

Project:  
**CAD MAPPING OF TEHSIL  
HEAD QUARTER HOSPITALS,  
PUNJAB**

|                                                                                         |                                                                                                    |
|-----------------------------------------------------------------------------------------|----------------------------------------------------------------------------------------------------|
| Client:<br><br>GOVERNMENT OF THE PUNJAB<br>PRIMARY & SECONDARY<br>HEALTHCARE DEPARTMENT | Consultant:<br><br>SKAFS CONSULTANT (Pvt.)<br>Limited<br>ENGINEERING AND ENVIRONMENT<br>CONSULTANT |
|-----------------------------------------------------------------------------------------|----------------------------------------------------------------------------------------------------|


Drawing Title:  
**THQ NOWSHERA VIRKAN  
HOSPITAL MASTER PLAN PART 2**

Drawing No.  
**SKAFS/NOWSHERA.VK /05**



# MASTER PLAN OF THQ HOSPITAL NOWSHERAVIRKAN

## PART 3

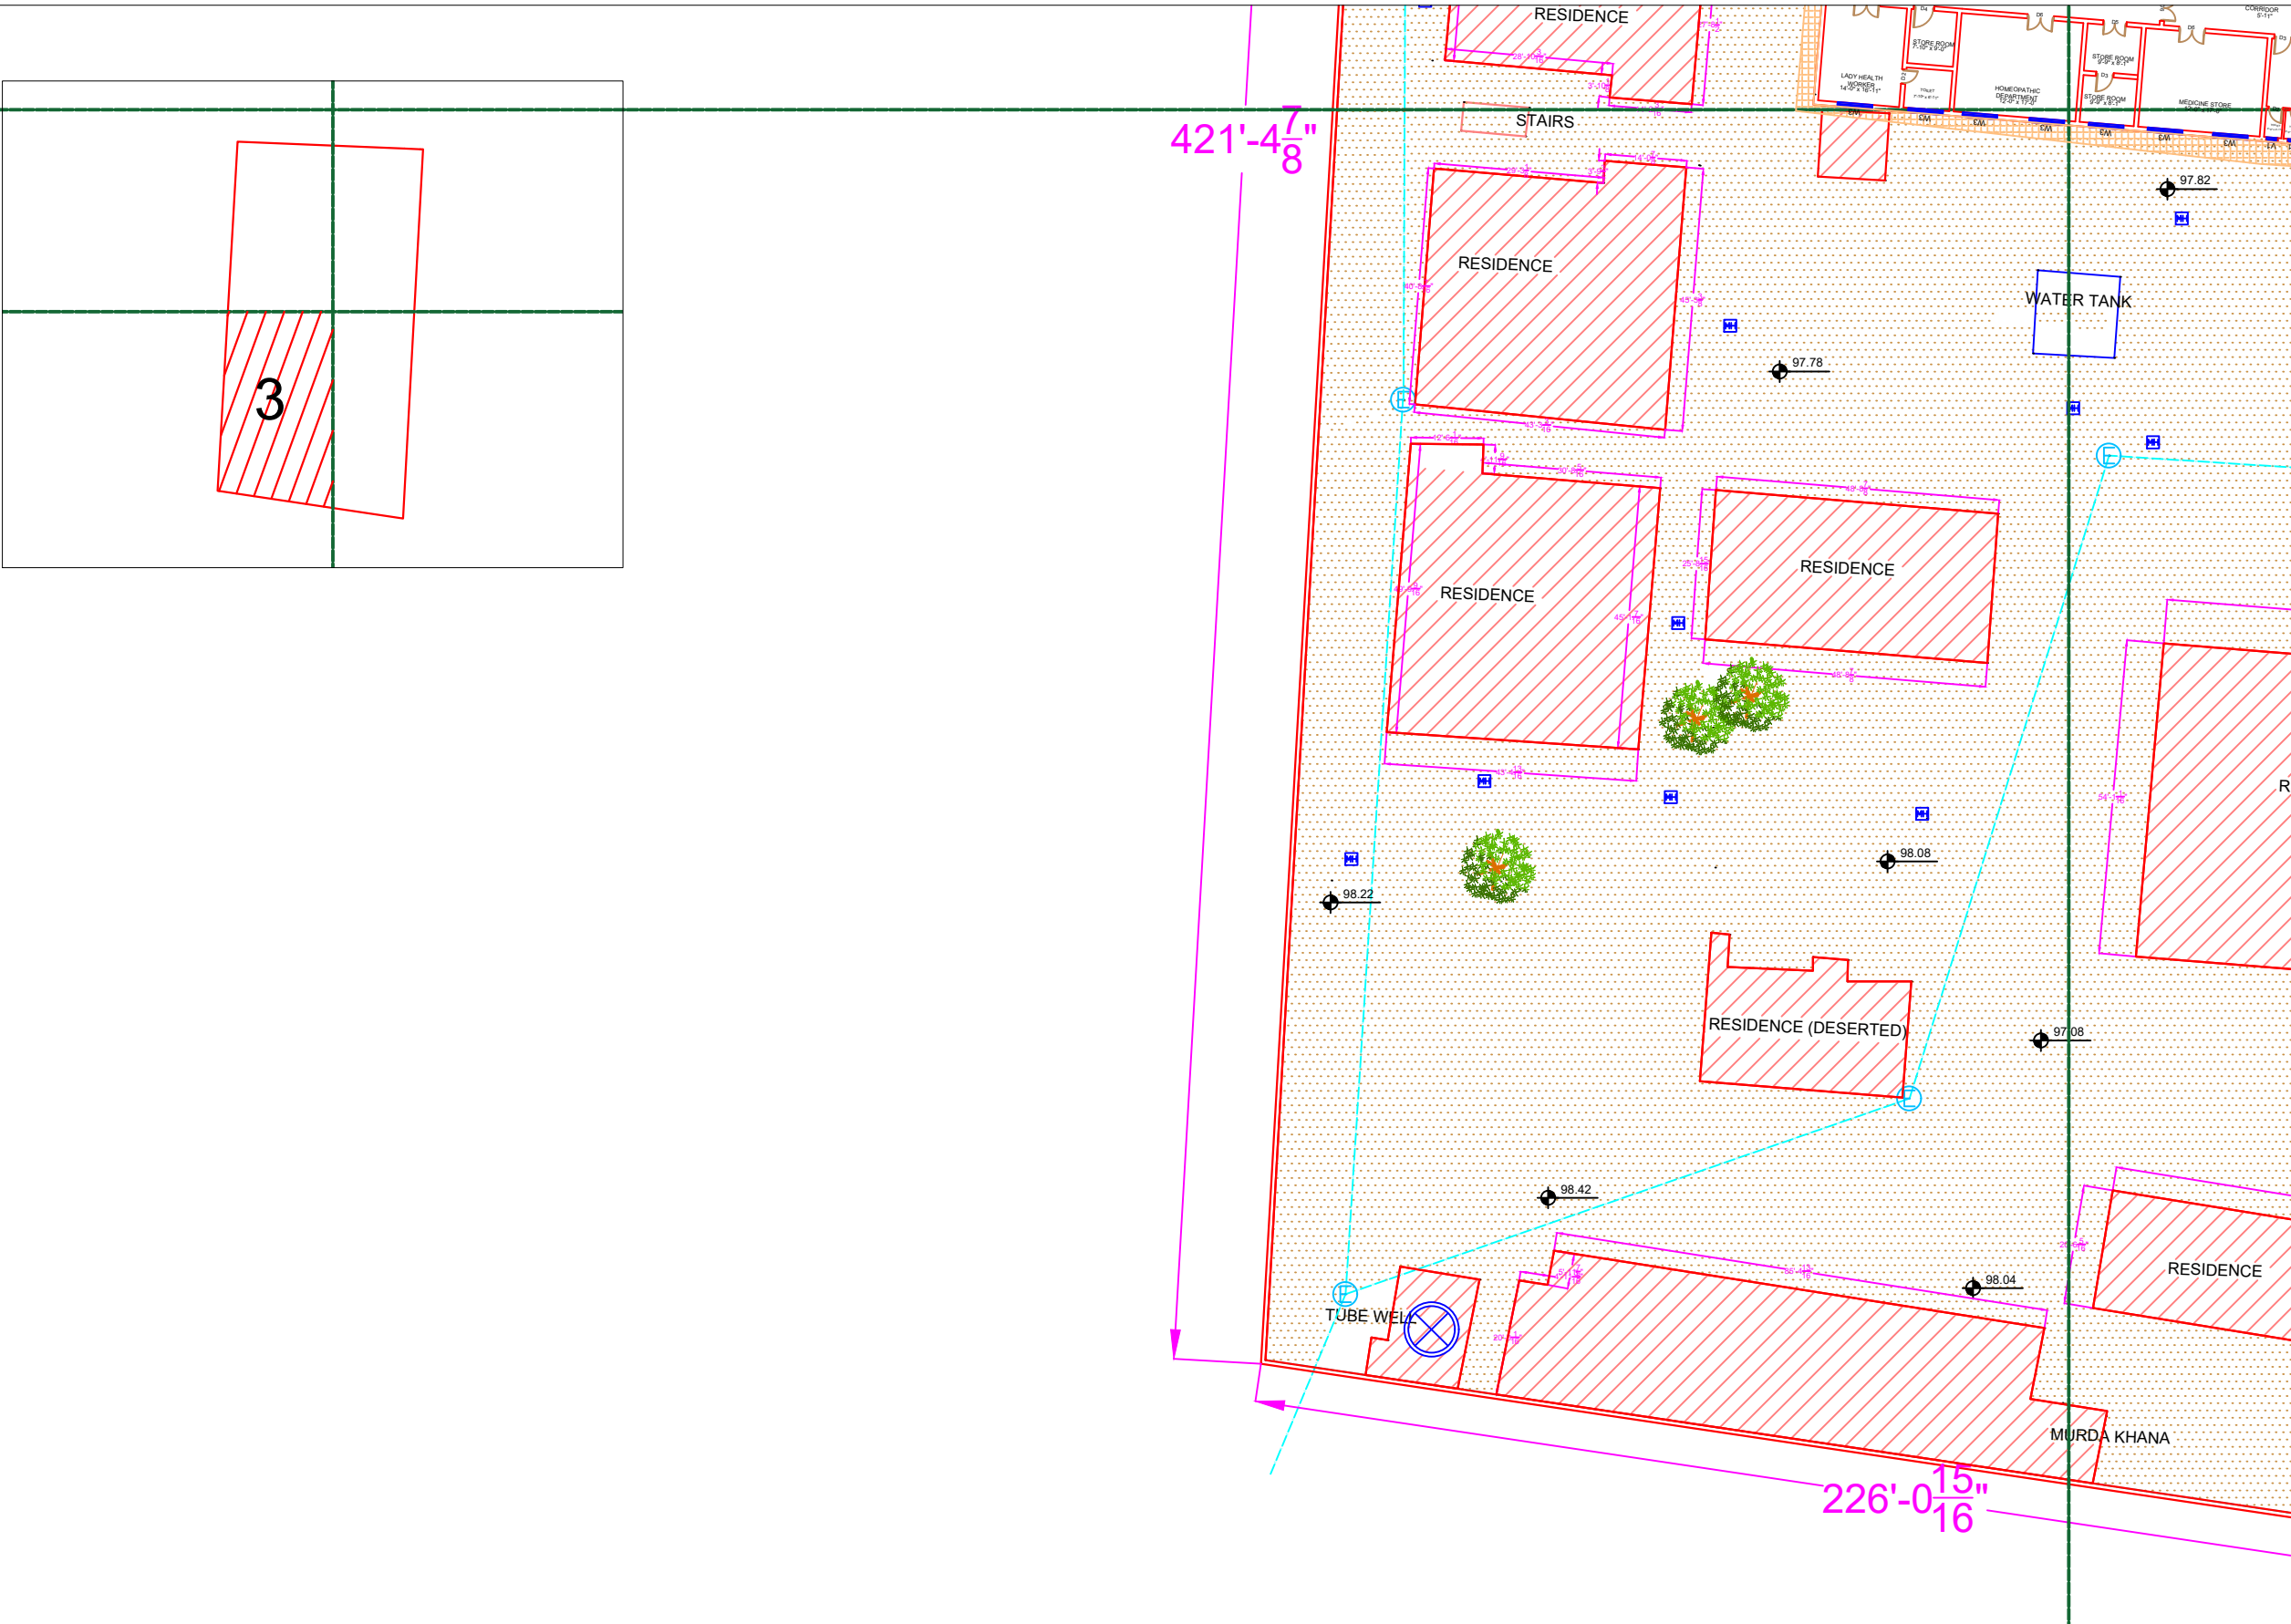

| Legends:                  |  |
|---------------------------|--|
| Residential Area          |  |
| Road                      |  |
| Wall                      |  |
| Power Line                |  |
| OHT                       |  |
| Tree                      |  |
| Man Hole                  |  |
| Tube Well                 |  |
| Light Pole                |  |
| Lawns                     |  |
| Earthen Areas             |  |
| Asphalts Roads            |  |
| Tough Pavers              |  |
| P.C.C / Plinth Protection |  |
| Boundary Wall             |  |
| Brick Pavers / Soling     |  |
| Drain                     |  |
| Tap                       |  |
| Hand Pump                 |  |
| Air Conditioner           |  |
| Tube Light                |  |
| Fan                       |  |
| Roof Light                |  |
| Bulb                      |  |


| AREA                      |              |
|---------------------------|--------------|
| AREA WITHIN BOUNDARY WALL | 97299.94 Sft |
| AREA OF CLINICAL BLOCK    | 21692.06 Sft |
| PLINTH AREA OF BLOCK      | 11681.95 Sft |

| OPENING SCHEDULE OF DOORS AND WINDOWS |       |        |         |       |        |
|---------------------------------------|-------|--------|---------|-------|--------|
| DOORS                                 | WIDTH | HEIGHT | WINDOWS | WIDTH | HEIGHT |
| D2                                    | 2'-6" | 7'-0"  | W1      | 3'-0" | 3'-0"  |
| D3                                    | 3'-0" | 7'-0"  | W2      | 4'-0" | 4'-0"  |
| D4                                    | 3'-6" | 7'-0"  | W3      | 6'-0" | 6'-0"  |
| D5                                    | 4'-0" | 7'-0"  | W4      | 8'-0" | 8'-0"  |
| D6                                    | 4'-6" | 7'-0"  | V1      | 2'-0" | 2'-0"  |
| D7                                    | 5'-0" | 7'-0"  |         |       |        |
|                                       |       |        |         |       |        |
|                                       |       |        |         |       |        |

|                                                                              |                                                                                     |
|------------------------------------------------------------------------------|-------------------------------------------------------------------------------------|
| Project:                                                                     |                                                                                     |
| CAD MAPPING OF TEHSIL HEAD QUARTER HOSPITALS, PUNJAB                         |                                                                                     |
| Client:                                                                      | Consultant:                                                                         |
| <br>GOVERNMENT OF THE PUNJAB<br>PRIMARY & SECONDARY<br>HEALTHCARE DEPARTMENT | <br>SKAFS CONSULTANT (Pvt.)<br>Limited<br>ENGINEERING AND ENVIRONMENT<br>CONSULTANT |
| Drawing Title:                                                               |                                                                                     |
| THQ NOWSHERA VIRKAN<br>HOSPITAL MASTER PLAN PART 3                           |                                                                                     |
| Drawing No.                                                                  |                                                                                     |
| SKAFS/NOWSHERA.VK /06                                                        |                                                                                     |

# MASTER PLAN OF THQ HOSPITAL NOWSHERAVIRKAN

## PART 4

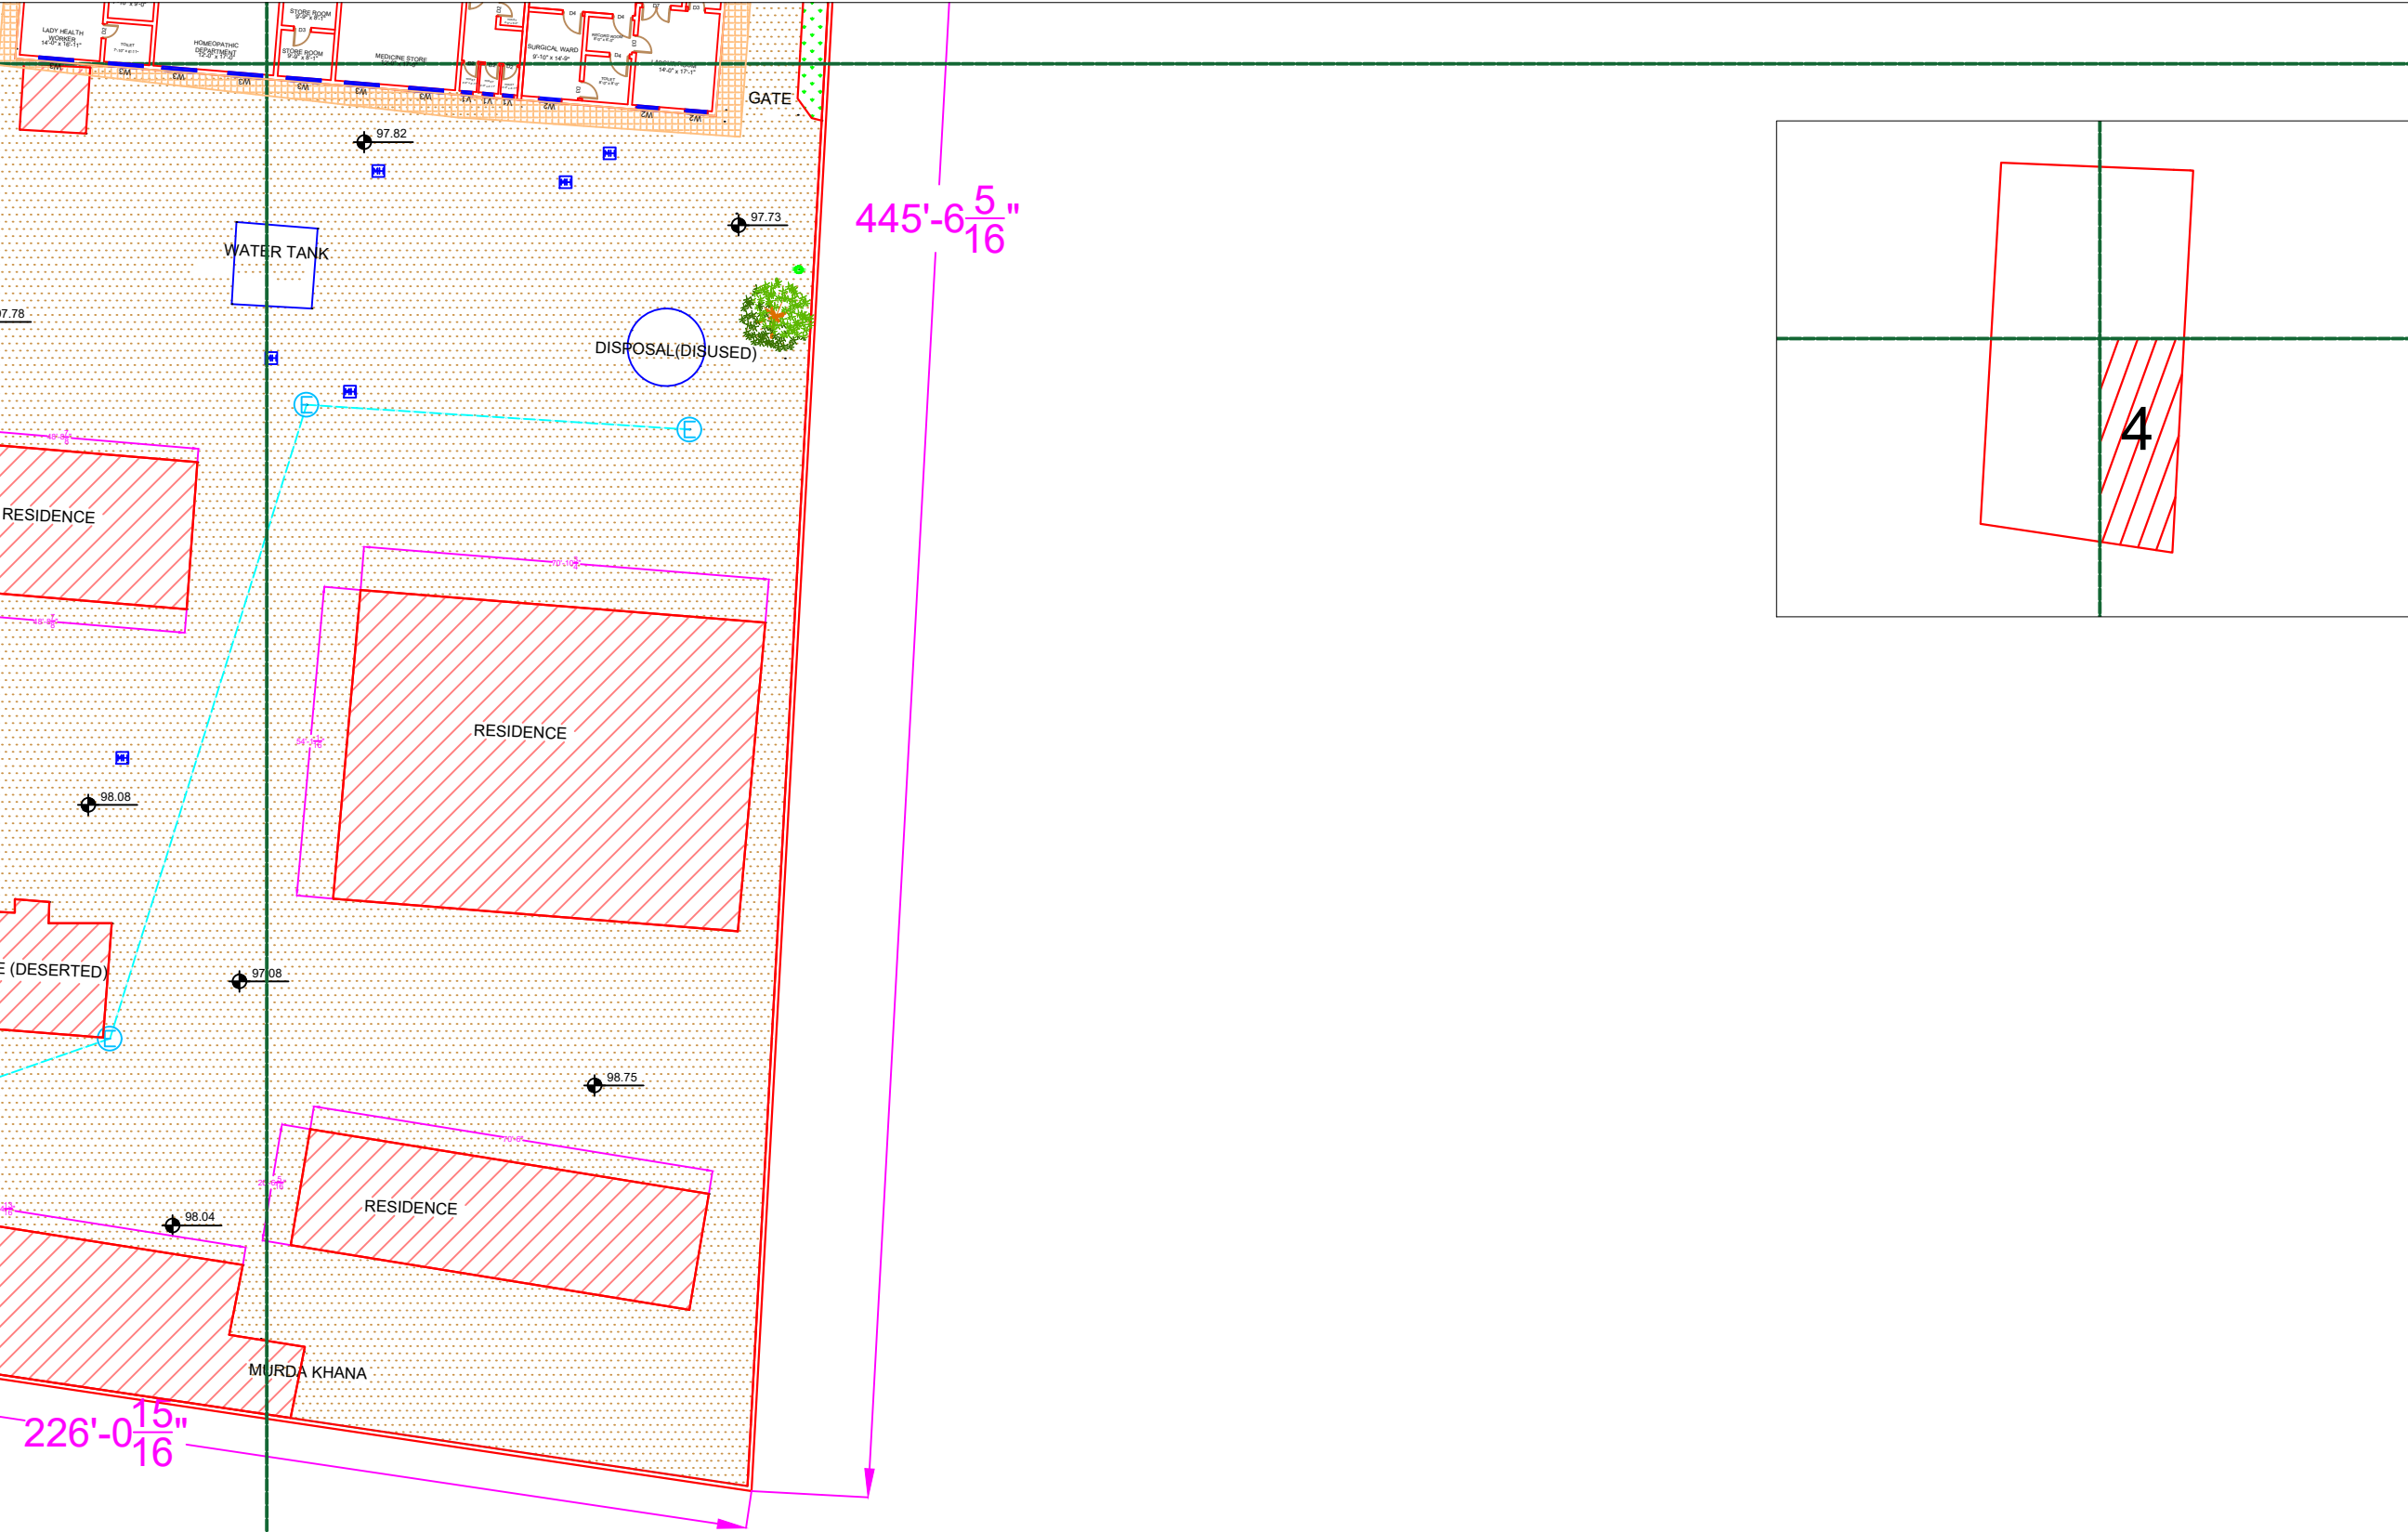

| Legends:                  |  |
|---------------------------|--|
| Residential Area          |  |
| Road                      |  |
| Wall                      |  |
| Power Line                |  |
| OHT                       |  |
| Tree                      |  |
| Man Hole                  |  |
| Tube Well                 |  |
| Light Pole                |  |
| Lawns                     |  |
| Earthen Areas             |  |
| Asphalts Roads            |  |
| Tough Pavers              |  |
| P.C.C / Plinth Protection |  |
| Boundary Wall             |  |
| Brick Pavers / Soling     |  |
| Drain                     |  |
| Tap                       |  |
| Hand Pump                 |  |
| Air Conditioner           |  |
| Tube Light                |  |
| Fan                       |  |
| Roof Light                |  |
| Bulb                      |  |

| AREA                      |              |
|---------------------------|--------------|
| AREA WITHIN BOUNDARY WALL | 97299.94 Sft |
| AREA OF CLINICAL BLOCK    | 21692.06 Sft |
| PLINTH AREA OF BLOCK      | 11681.95 Sft |

| OPENING SCHEDULE OF DOORS AND WINDOWS |       |        |         |       |        |
|---------------------------------------|-------|--------|---------|-------|--------|
| DOORS                                 | WIDTH | HEIGHT | WINDOWS | WIDTH | HEIGHT |
| D2                                    | 2'-6" | 7'-0"  | W1      | 3'-0" | 3'-0"  |
| D3                                    | 3'-0" | 7'-0"  | W2      | 4'-0" | 4'-0"  |
| D4                                    | 3'-6" | 7'-0"  | W3      | 6'-0" | 6'-0"  |
| D5                                    | 4'-0" | 7'-0"  | W4      | 8'-0" | 8'-0"  |
| D6                                    | 4'-6" | 7'-0"  | V1      | 2'-0" | 2'-0"  |
| D7                                    | 5'-0" | 7'-0"  |         |       |        |
|                                       |       |        |         |       |        |
|                                       |       |        |         |       |        |

Project:  
**CAD MAPPING OF TEHSIL  
HEAD QUARTER HOSPITALS,  
PUNJAB**

Client:  
  
GOVERNMENT OF THE PUNJAB  
PRIMARY & SECONDARY  
HEALTHCARE DEPARTMENT


Consultant:  
  
SKAFS CONSULTANT (Pvt.)  
Limited  
ENGINEERING AND ENVIRONMENT  
CONSULTANT

Drawing Title:  
**THQ NOWSHERA VIRKAN  
HOSPITAL MASTER PLAN PART 4**

Drawing No.  
**SKAFS/NOWSHERA.VK /07**

# CLINICAL BLOCK OF THQ HOSPITAL NOWSHERA VIRKAN

## GROUND FLOOR

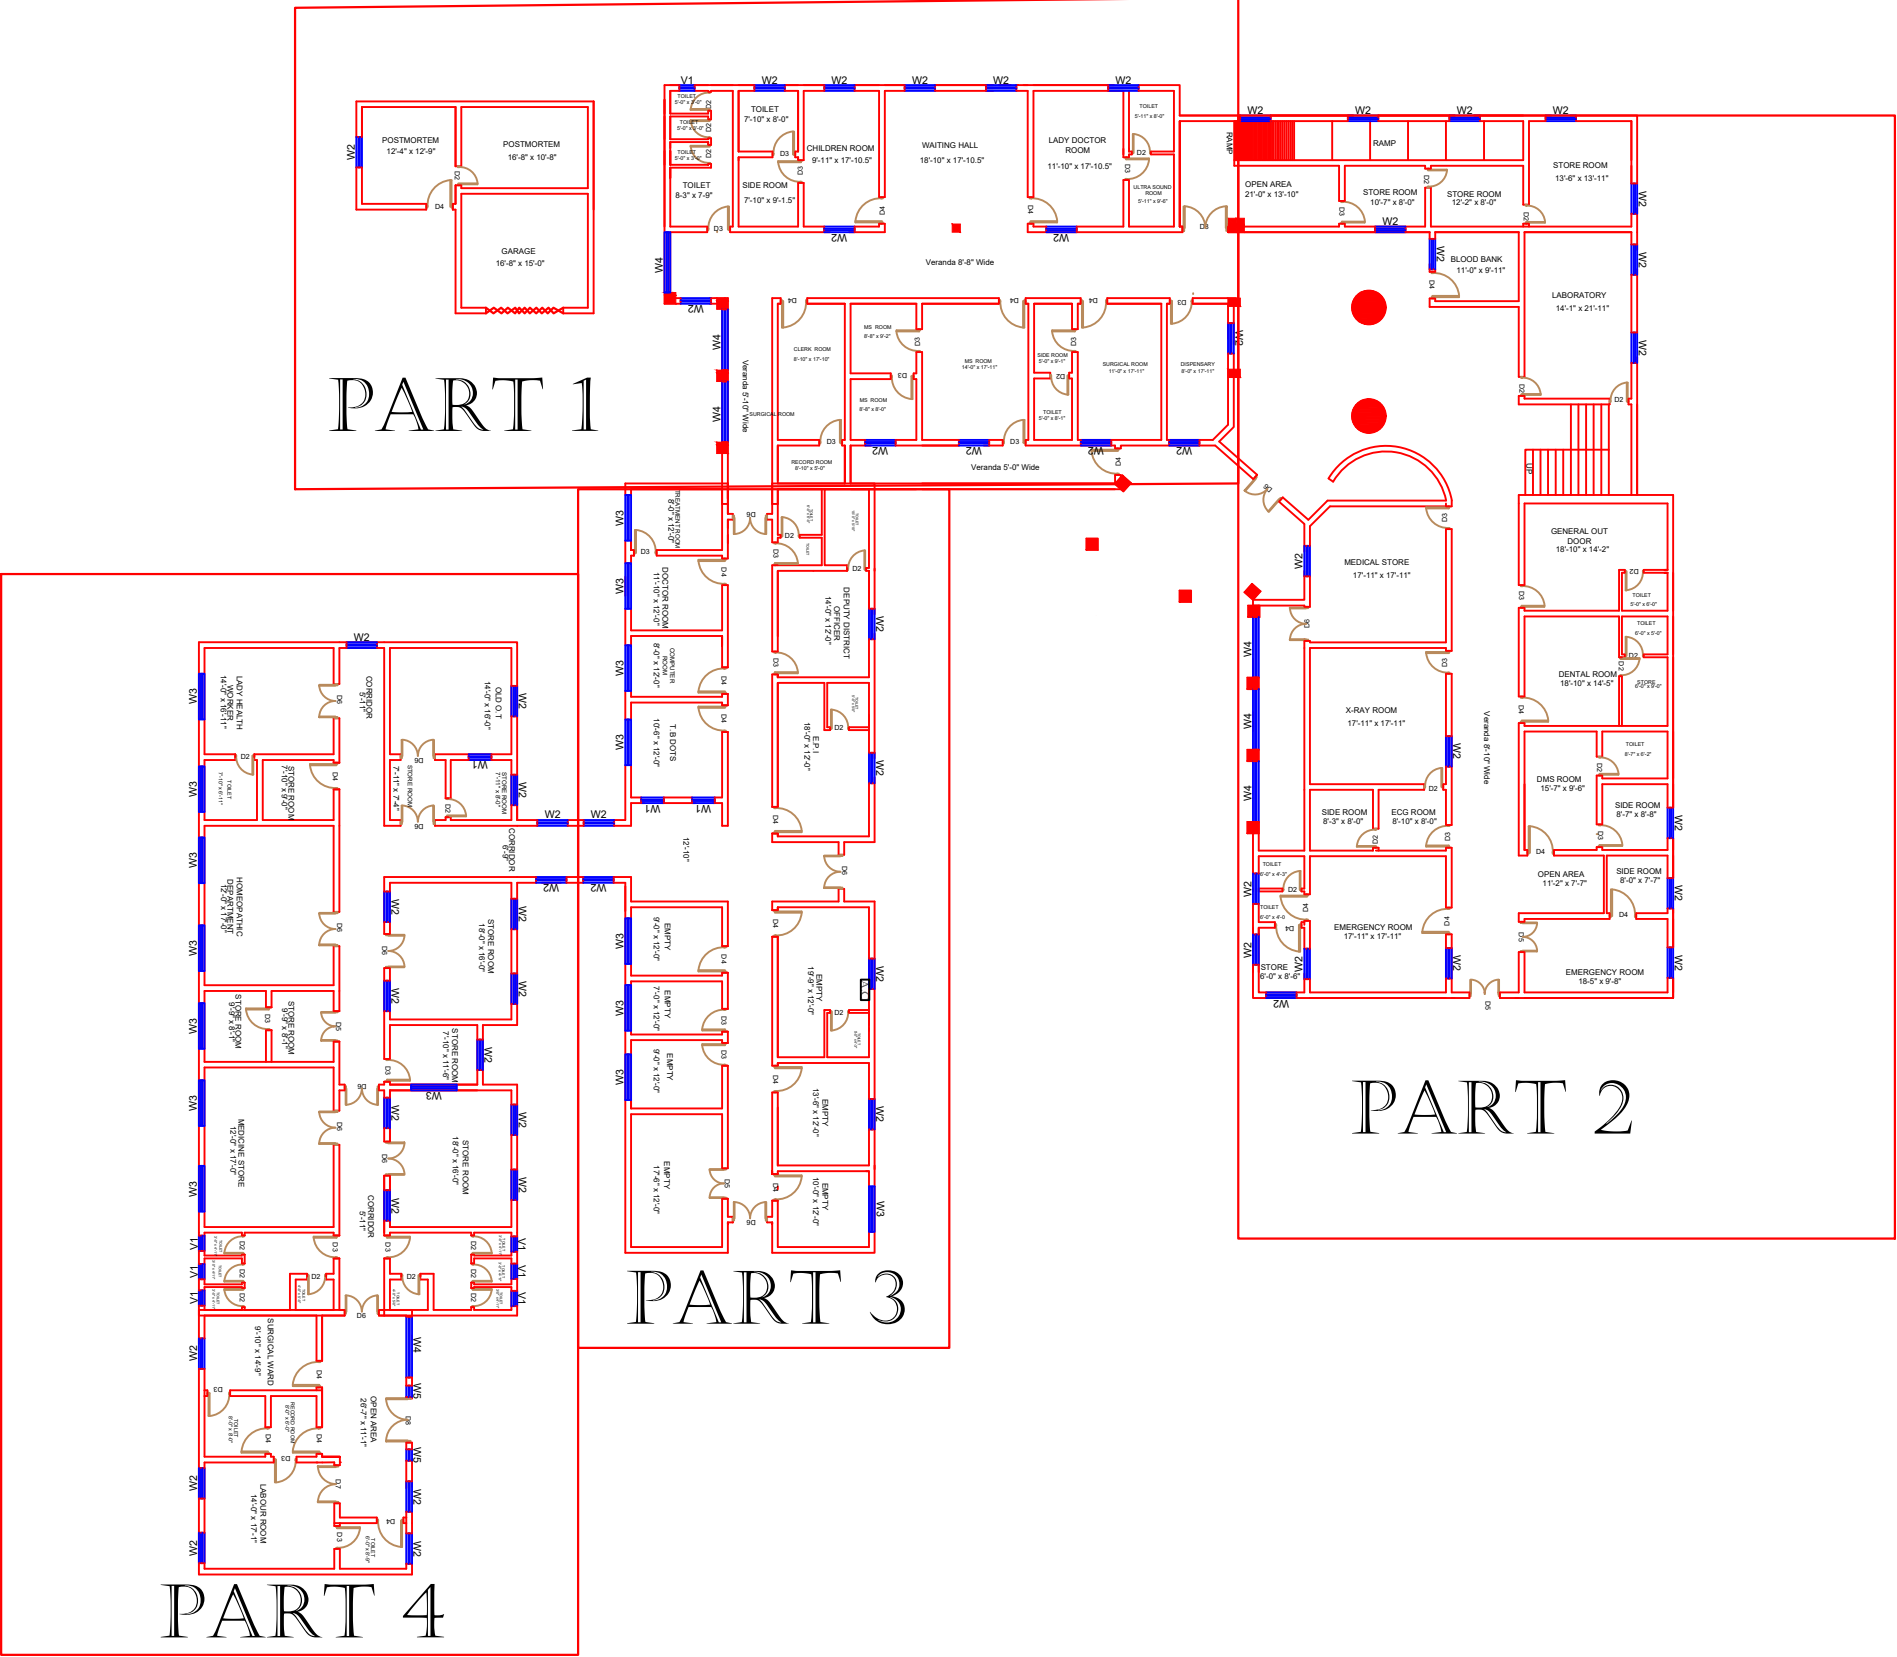

**Legends:**

|                           |  |
|---------------------------|--|
| Residential Area          |  |
| Road                      |  |
| Wall                      |  |
| Power Line                |  |
| OHT                       |  |
| Tree                      |  |
| Man Hole                  |  |
| Tube Well                 |  |
| Light Pole                |  |
| Lawns                     |  |
| Earthen Areas             |  |
| Asphalts Roads            |  |
| Tough Pavers              |  |
| P.C.C / Plinth Protection |  |
| Boundary Wall             |  |
| Brick Pavers / Soling     |  |
| Drain                     |  |
| Tap                       |  |
| Hand Pump                 |  |
| Air Conditioner           |  |
| Tube Light                |  |
| Fan                       |  |
| Roof Light                |  |
| Bulb                      |  |

| AREA                      |  |              |  |  |  |
|---------------------------|--|--------------|--|--|--|
| AREA WITHIN BOUNDARY WALL |  | 97299.94 Sft |  |  |  |
| AREA OF CLINICAL BLOCK    |  | 21692.06 Sft |  |  |  |
| PLINTH AREA OF BLOCK      |  | 11681.95 Sft |  |  |  |

| OPENING SCHEDULE OF DOORS AND WINDOWS |       |        |         |       |        |
|---------------------------------------|-------|--------|---------|-------|--------|
| DOORS                                 | WIDTH | HEIGHT | WINDOWS | WIDTH | HEIGHT |
| D2                                    | 2'-6" | 7'-0"  | W1      | 3'-0" | 3'-0"  |
| D3                                    | 3'-0" | 7'-0"  | W2      | 4'-0" | 4'-0"  |
| D4                                    | 3'-6" | 7'-0"  | W3      | 6'-0" | 6'-0"  |
| D5                                    | 4'-0" | 7'-0"  | W4      | 8'-0" | 8'-0"  |
| D6                                    | 4'-6" | 7'-0"  | V1      | 2'-0" | 2'-0"  |
| D7                                    | 5'-0" | 7'-0"  |         |       |        |
|                                       |       |        |         |       |        |
|                                       |       |        |         |       |        |
|                                       |       |        |         |       |        |

Project:  
**CAD MAPPING OF TEHSIL  
HEAD QUARTER HOSPITALS,  
PUNJAB**


|                                                                                         |                                                                                                    |
|-----------------------------------------------------------------------------------------|----------------------------------------------------------------------------------------------------|
| Client:<br><br>GOVERNMENT OF THE PUNJAB<br>PRIMARY & SECONDARY<br>HEALTHCARE DEPARTMENT | Consultant:<br><br>SKAFS CONSULTANT (Pvt.)<br>Limited<br>ENGINEERING AND ENVIRONMENT<br>CONSULTANT |
|-----------------------------------------------------------------------------------------|----------------------------------------------------------------------------------------------------|

Drawing Title:  
**THQ NOWSHERA VIRKAN  
HOSPITAL CLINICAL BLOCK PLAN**

Drawing No.  
**SKAFS/NOWSHERA.VK /08**

# CLINICAL BLOCK OF THQ HOSPITAL NOWSHERA VIRKAN

## GROUND FLOOR PART 1

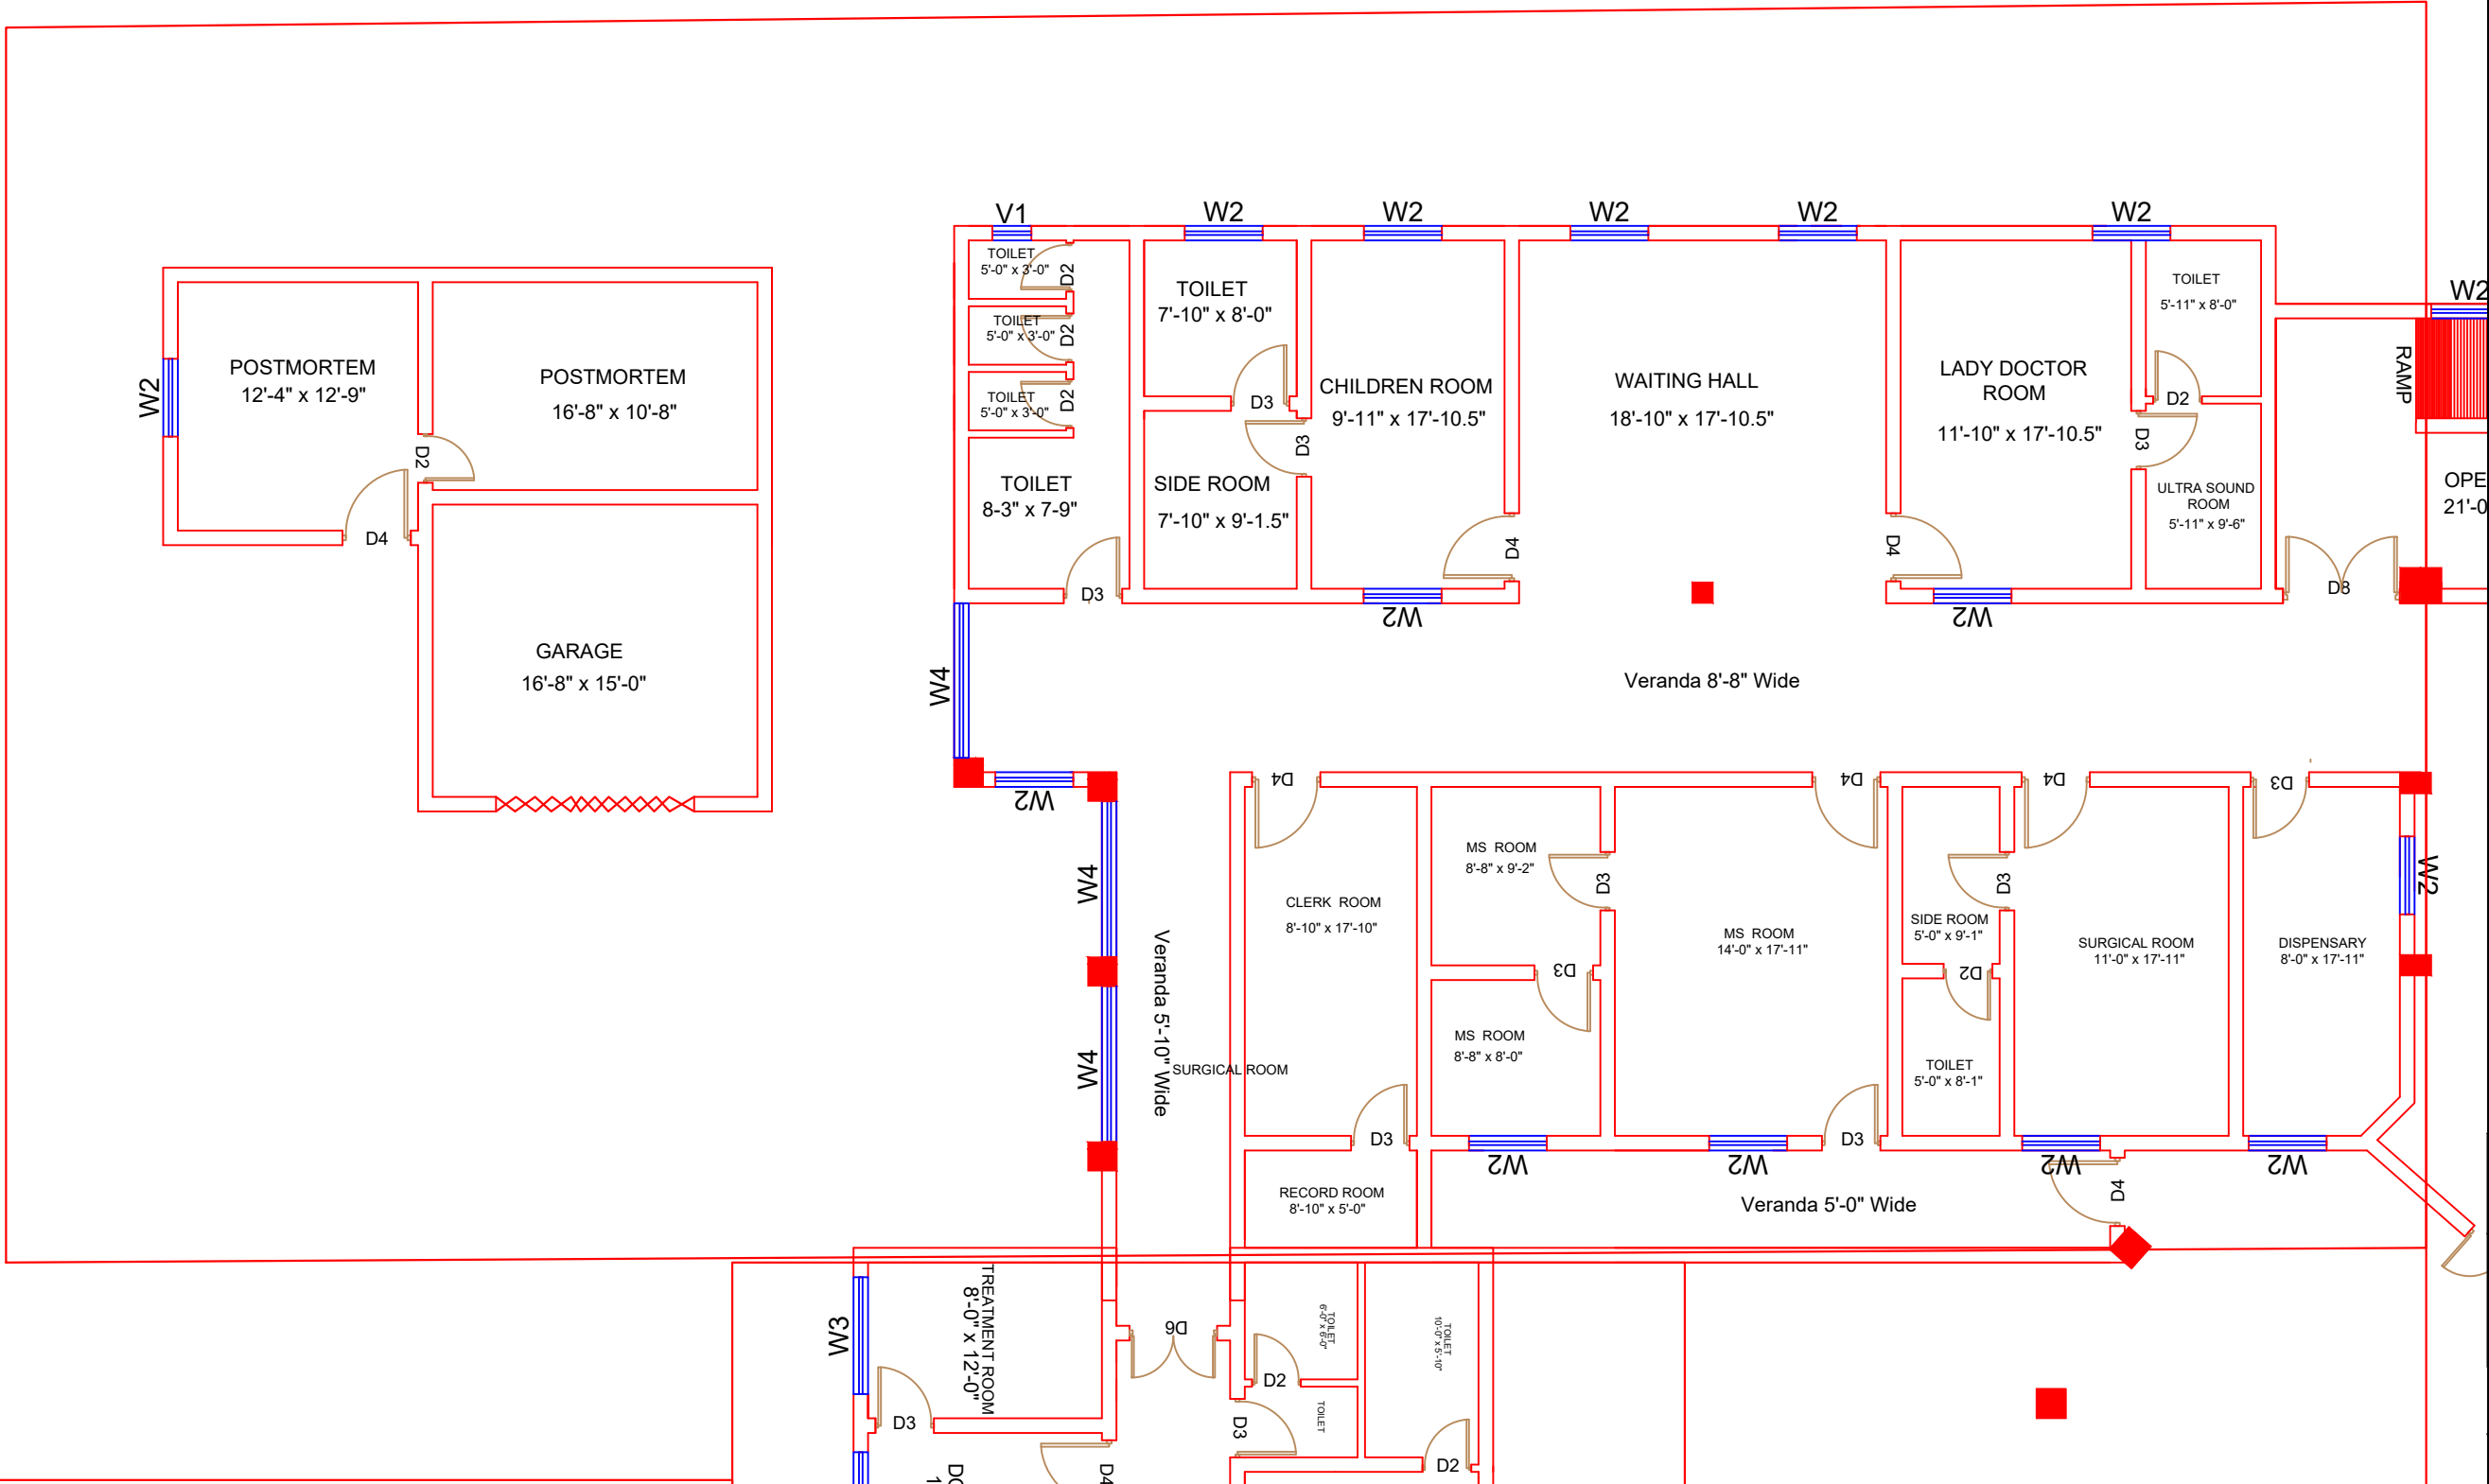

**Legends:**

|                           |  |
|---------------------------|--|
| Residential Area          |  |
| Road                      |  |
| Wall                      |  |
| Power Line                |  |
| OHT                       |  |
| Tree                      |  |
| Man Hole                  |  |
| Tube Well                 |  |
| Light Pole                |  |
| Lawns                     |  |
| Earthen Areas             |  |
| Asphalts Roads            |  |
| Tough Pavers              |  |
| P.C.C / Plinth Protection |  |
| Boundary Wall             |  |
| Brick Pavers / Soling     |  |
| Drain                     |  |
| Tap                       |  |
| Hand Pump                 |  |
| Air Conditioner           |  |
| Tube Light                |  |
| Fan                       |  |
| Roof Light                |  |
| Bulb                      |  |

| AREA                      |              |
|---------------------------|--------------|
| AREA WITHIN BOUNDARY WALL | 97299.94 Sft |
| AREA OF CLINICAL BLOCK    | 21692.06 Sft |
| PLINTH AREA OF BLOCK      | 11681.95 Sft |

| OPENING SCHEDULE OF DOORS AND WINDOWS |       |        |         |       |        |
|---------------------------------------|-------|--------|---------|-------|--------|
| DOORS                                 | WIDTH | HEIGHT | WINDOWS | WIDTH | HEIGHT |
| D2                                    | 2'-6" | 7'-0"  | W1      | 3'-0" | 3'-0"  |
| D3                                    | 3'-0" | 7'-0"  | W2      | 4'-0" | 4'-0"  |
| D4                                    | 3'-6" | 7'-0"  | W3      | 6'-0" | 6'-0"  |
| D5                                    | 4'-0" | 7'-0"  | W4      | 8'-0" | 8'-0"  |
| D6                                    | 4'-6" | 7'-0"  | V1      | 2'-0" | 2'-0"  |
| D7                                    | 5'-0" | 7'-0"  |         |       |        |
|                                       |       |        |         |       |        |
|                                       |       |        |         |       |        |
|                                       |       |        |         |       |        |

Project: **CAD MAPPING OF TEHSIL HEAD QUARTER HOSPITALS, PUNJAB**


|                                                                                     |                                                                                                |
|-------------------------------------------------------------------------------------|------------------------------------------------------------------------------------------------|
| Client:<br>GOVERNMENT OF THE PUNJAB<br>PRIMARY & SECONDARY<br>HEALTHCARE DEPARTMENT | Consultant:<br>SKAFS CONSULTANT (Pvt.)<br>Limited<br>ENGINEERING AND ENVIRONMENT<br>CONSULTANT |
|-------------------------------------------------------------------------------------|------------------------------------------------------------------------------------------------|

Drawing Title: **THQ NOWSHERA VIRKAN CLINICAL BLOCK PLAN (PART 1)**

Drawing No. **SKAFS/NOWSHERA.VK /09**

# CLINICAL BLOCK OF THQ HOSPITAL NOWSHERA VIRKAN

## GROUND FLOOR PART 2

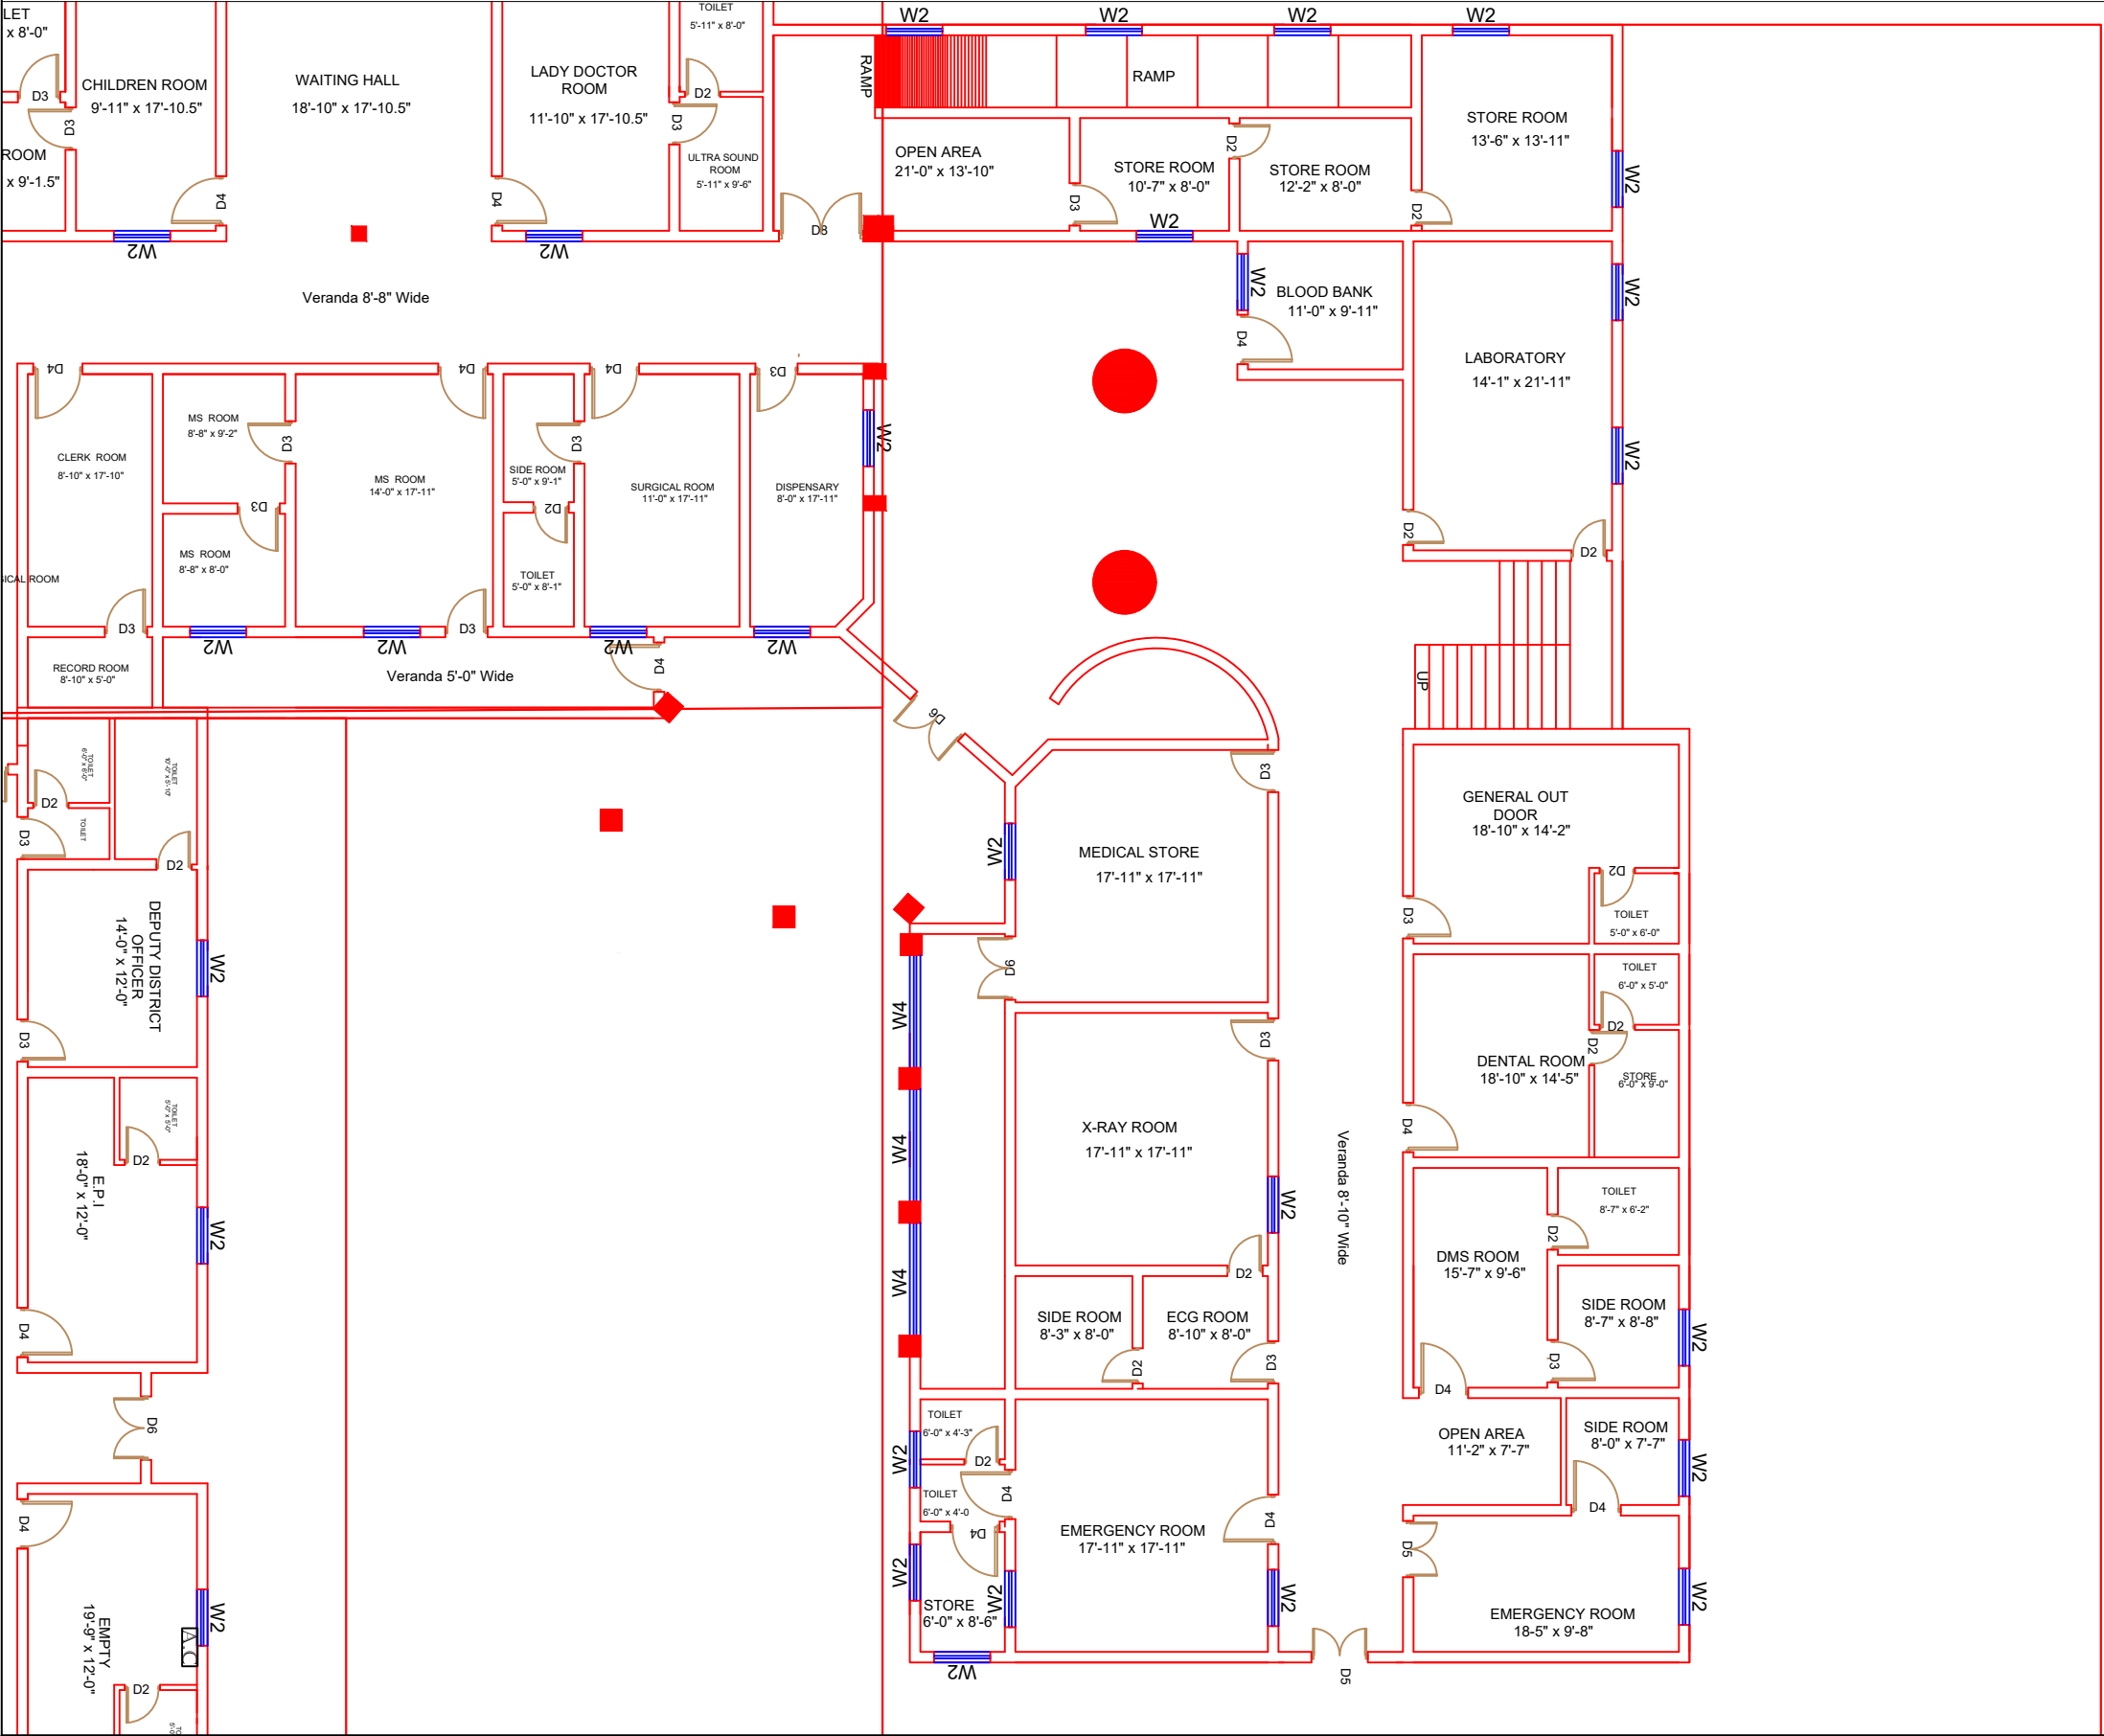

**Legends:**

|                           |  |
|---------------------------|--|
| Residential Area          |  |
| Road                      |  |
| Wall                      |  |
| Power Line                |  |
| OHT                       |  |
| Tree                      |  |
| Man Hole                  |  |
| Tube Well                 |  |
| Light Pole                |  |
| Lawns                     |  |
| Earthen Areas             |  |
| Asphalts Roads            |  |
| Tough Pavers              |  |
| P.C.C / Plinth Protection |  |
| Boundary Wall             |  |
| Brick Pavers / Soling     |  |
| Drain                     |  |
| Tap                       |  |
| Hand Pump                 |  |
| Air Conditioner           |  |
| Tube Light                |  |
| Fan                       |  |
| Roof Light                |  |
| Bulb                      |  |

| AREA                      |              |  |  |  |  |
|---------------------------|--------------|--|--|--|--|
| AREA WITHIN BOUNDARY WALL | 97299.94 Sft |  |  |  |  |
| AREA OF CLINICAL BLOCK    | 21692.06 Sft |  |  |  |  |
| PLINTH AREA OF BLOCK      | 11681.95 Sft |  |  |  |  |

| OPENING SCHEDULE OF DOORS AND WINDOWS |       |        |         |       |        |
|---------------------------------------|-------|--------|---------|-------|--------|
| DOORS                                 | WIDTH | HEIGHT | WINDOWS | WIDTH | HEIGHT |
| D2                                    | 2'-6" | 7'-0"  | W1      | 3'-0" | 3'-0"  |
| D3                                    | 3'-0" | 7'-0"  | W2      | 4'-0" | 4'-0"  |
| D4                                    | 3'-6" | 7'-0"  | W3      | 6'-0" | 6'-0"  |
| D5                                    | 4'-0" | 7'-0"  | W4      | 8'-0" | 8'-0"  |
| D6                                    | 4'-6" | 7'-0"  | V1      | 2'-0" | 2'-0"  |
| D7                                    | 5'-0" | 7'-0"  |         |       |        |
|                                       |       |        |         |       |        |
|                                       |       |        |         |       |        |
|                                       |       |        |         |       |        |

Project: CAD MAPPING OF TEHSIL HEAD QUARTER HOSPITALS, PUNJAB

|                                                                                         |                                                                                                    |
|-----------------------------------------------------------------------------------------|----------------------------------------------------------------------------------------------------|
| Client:<br><br>GOVERNMENT OF THE PUNJAB<br>PRIMARY & SECONDARY<br>HEALTHCARE DEPARTMENT | Consultant:<br><br>SKAFS CONSULTANT (Pvt.)<br>Limited<br>ENGINEERING AND ENVIRONMENT<br>CONSULTANT |
|-----------------------------------------------------------------------------------------|----------------------------------------------------------------------------------------------------|

Drawing Title: THQ NOWSHERA VIRKAN  
CLINICAL BLOCK PLAN (PART 2)

Drawing No. SKAFS/NOWSHERA.VK /10



# CLINICAL BLOCK OF THQ HOSPITAL NOWSHERA VIRKAN

## GROUND FLOOR PART 3

The floor plan is divided into several sections by corridors. The top section contains the Deputy District Officer's office (14'-0" x 12'-0"), E.P.I. room (18'-0" x 12'-0"), TB DOTS room (10'-6" x 12'-0"), Computer Room (8'-0" x 12'-0"), Doctor Room (11'-10" x 12'-0"), and Treatment Room (8'-0" x 12'-0"). The middle section includes an Old O.T. (14'-0" x 16'-0"), Store Room (7'-11" x 8'-0"), Store Room (7'-11" x 7'-4"), and a Corridor (8'-9"). The bottom section features a Lady Health Worker room (14'-0" x 16'-11"), Store Room (7'-10" x 9'-0"), Homeopathic Department (12'-0" x 17'-0"), Store Room (9'-9" x 8'-1"), Medicine Store (12'-0" x 17'-0"), and several empty rooms (9'-0" x 12'-0", 7'-0" x 12'-0", 9'-0" x 12'-0", 13'-6" x 12'-0", 10'-0" x 12'-0", 17'-6" x 12'-0"). The plan also shows various toilets, doors (D1-D6), and windows (W1-W3). A side entrance is located on the right side of the plan.

|                           |                                                                                       |
|---------------------------|---------------------------------------------------------------------------------------|
| Residential Area          |    |
| Road                      |    |
| Wall                      |    |
| Power Line                |    |
| OHT                       |    |
| Tree                      |    |
| Man Hole                  |    |
| Tube Well                 |    |
| Light Pole                |    |
| Lawns                     |    |
| Earthen Areas             |    |
| Asphalts Roads            |    |
| Tough Pavers              |    |
| P.C.C / Plinth Protection |    |
| Boundary Wall             |    |
| Brick Pavers / Soling     |    |
| Drain                     |    |
| Tap                       |    |
| Hand Pump                 |  |
| Air Conditioner           |  |
| Tube Light                |  |
| Fan                       |  |
| Roof Light                |  |
| Bulb                      |  |

| AREA                      |              |
|---------------------------|--------------|
| AREA WITHIN BOUNDARY WALL | 97299.94 Sft |
| AREA OF CLINICAL BLOCK    | 21692.06 Sft |
| PLINTH AREA OF BLOCK      | 11681.95 Sft |

[illegible]


Project:  
**CAD MAPPING OF TEHSIL  
HEAD QUARTER HOSPITALS,  
PUNJAB**

|                                                                                                                                                                                                                    |                                                                                                                                                                                                                                            |
|--------------------------------------------------------------------------------------------------------------------------------------------------------------------------------------------------------------------|--------------------------------------------------------------------------------------------------------------------------------------------------------------------------------------------------------------------------------------------|
| <p><b>Client:</b></p>  <p>GOVERNMENT OF THE PUNJAB<br/> <b>PRIMARY &amp; SECONDARY<br/>         HEALTHCARE DEPARTMENT</b></p> | <p><b>Consultant:</b></p>  <p><b>SKAFS CONSULTANT (Pvt.)<br/>         Limited</b><br/> <i>ENGINEERING AND ENVIRONMENT<br/>         CONSULTANT</i></p> |
|--------------------------------------------------------------------------------------------------------------------------------------------------------------------------------------------------------------------|--------------------------------------------------------------------------------------------------------------------------------------------------------------------------------------------------------------------------------------------|

Drawing Title: **THQ NOWSHERA VIRKAN  
CLINICAL BLOCK PLAN (PART 3)**

Drawing No. **SKAFS/NOWSHERA.VK** /1

CLINICAL BLOCK OF THQ HOSPITAL NOWSHERAVIRKAN  
GROUND FLOOR PART 4

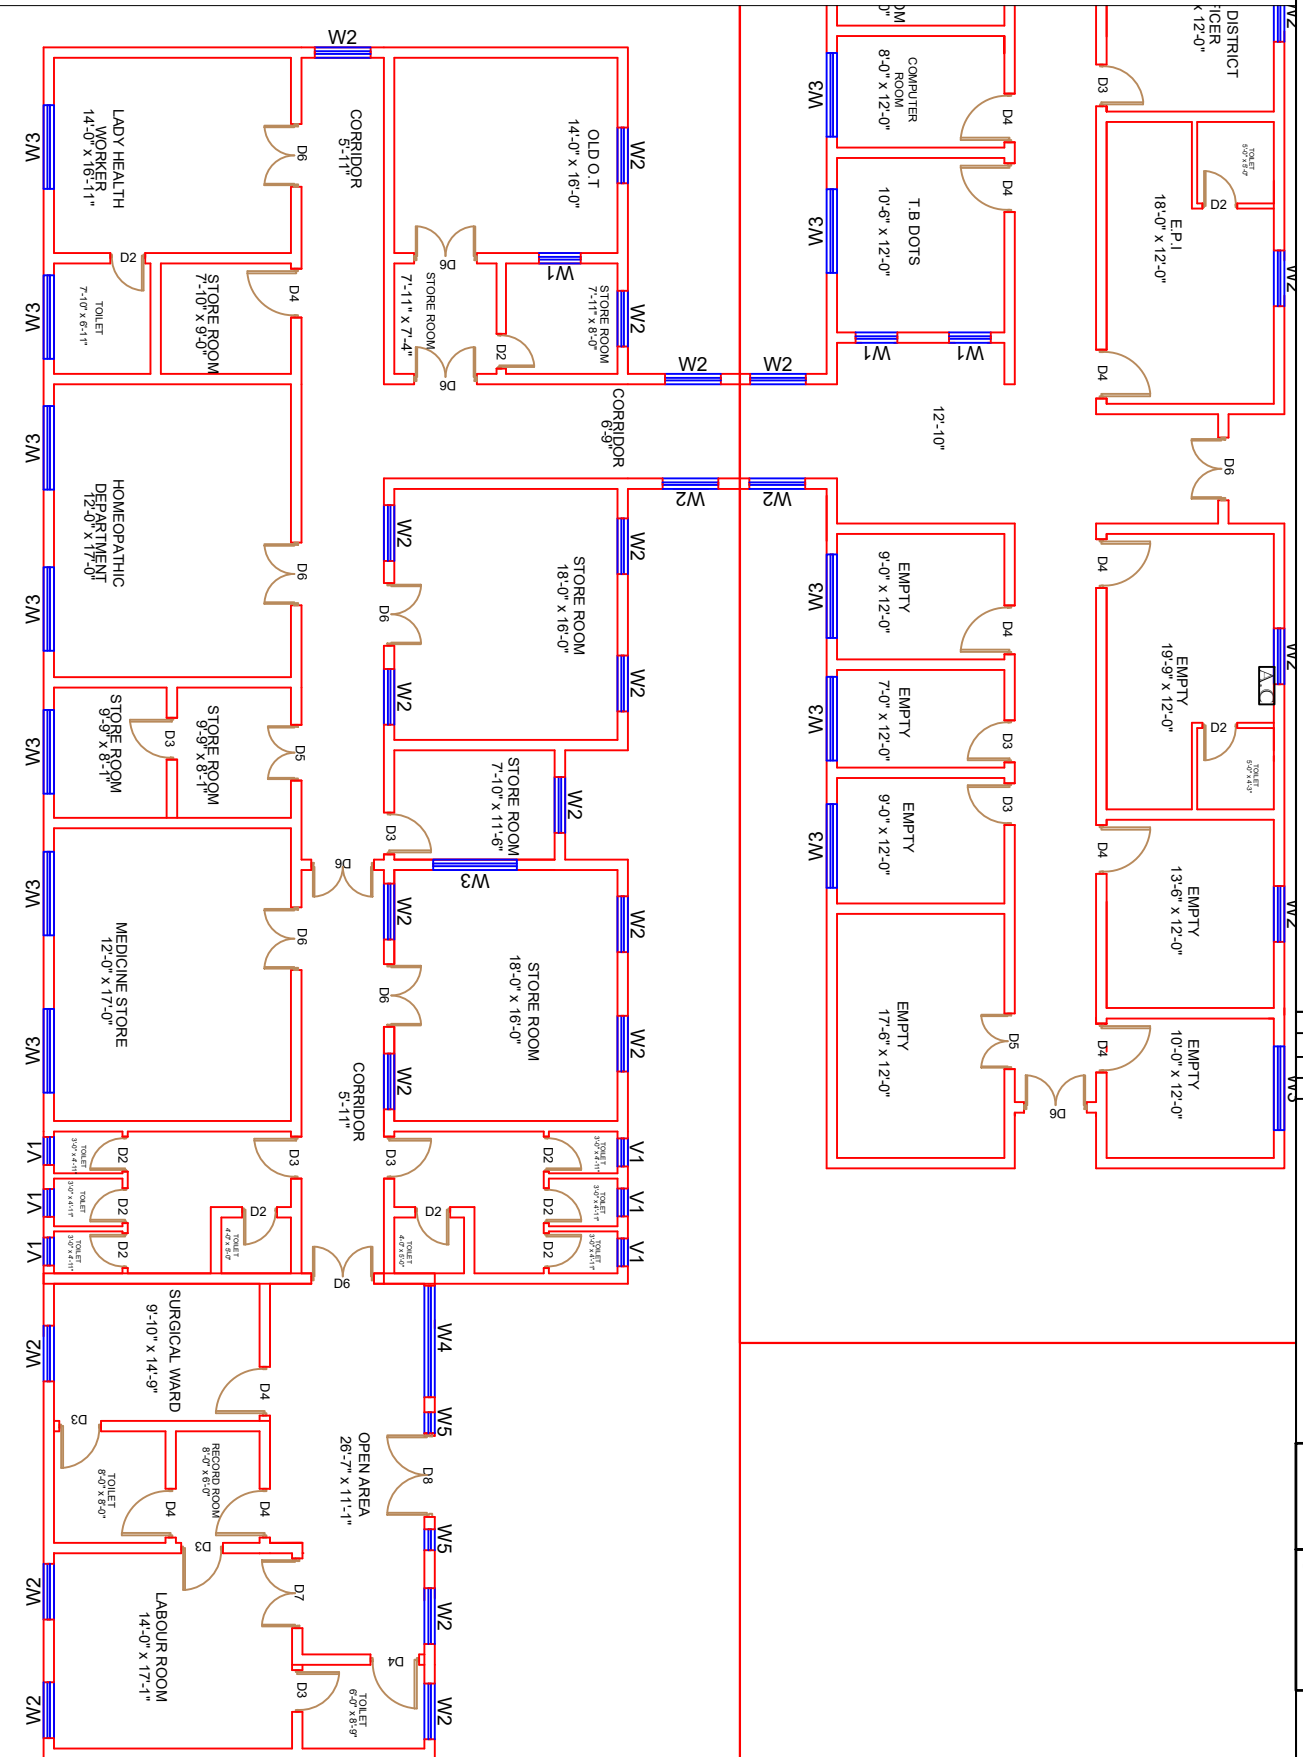

| Legends:                  |                                                                                       |
|---------------------------|---------------------------------------------------------------------------------------|
| Residential Area          |    |
| Road                      |    |
| Wall                      |    |
| Power Line                |    |
| OHT                       |    |
| Tree                      |    |
| Man Hole                  |    |
| Tube Well                 |    |
| Light Pole                |    |
| Lawns                     |    |
| Earthen Areas             |    |
| Asphalts Roads            |    |
| Tough Pavers              |    |
| P.C.C / Plinth Protection |    |
| Boundary Wall             |    |
| Brick Pavers / Soling     |    |
| Drain                     |    |
| Tap                       |  |
| Hand Pump                 |  |
| Air Conditioner           |  |
| Tube Light                |  |
| Fan                       |  |
| Roof Light                |  |
| Bulb                      |  |

| AREA                      |              |
|---------------------------|--------------|
| AREA WITHIN BOUNDARY WALL | 97299.94 Sft |
| AREA OF CLINICAL BLOCK    | 21692.06 Sft |
| PLINTH AREA OF BLOCK      | 11681.95 Sft |

| OPENING SCHEDULE OF DOORS AND WINDOWS |       |        |         |       |        |
|---------------------------------------|-------|--------|---------|-------|--------|
| DOORS                                 | WIDTH | HEIGHT | WINDOWS | WIDTH | HEIGHT |
| D2                                    | 2'-6" | 7'-0"  | W1      | 3'-0" | 3'-0"  |
| D3                                    | 3'-0" | 7'-0"  | W2      | 4'-0" | 4'-0"  |
| D4                                    | 3'-6" | 7'-0"  | W3      | 6'-0" | 6'-0"  |
| D5                                    | 4'-0" | 7'-0"  | W4      | 8'-0" | 8'-0"  |
| D6                                    | 4'-6" | 7'-0"  | V1      | 2'-0" | 2'-0"  |
| D7                                    | 5'-0" | 7'-0"  |         |       |        |
|                                       |       |        |         |       |        |
|                                       |       |        |         |       |        |
|                                       |       |        |         |       |        |


Project:  
**CAD MAPPING OF TEHSIL  
HEAD QUARTER HOSPITALS,  
PUNJAB**

|                                                                                                                                                                                                          |                                                                                                                                                                                                                                  |
|----------------------------------------------------------------------------------------------------------------------------------------------------------------------------------------------------------|----------------------------------------------------------------------------------------------------------------------------------------------------------------------------------------------------------------------------------|
| <p><b>Client:</b></p>  <p>GOVERNMENT OF THE PUNJAB<br/><b>PRIMARY &amp; SECONDARY<br/>HEALTHCARE DEPARTMENT</b></p> | <p><b>Consultant:</b></p>  <p><b>SKAFS CONSULTANT (PVT.)</b><br/><b>Limited</b><br/><i>ENGINEERING AND ENVIRONMENTAL<br/>CONSULTANT</i></p> |
|----------------------------------------------------------------------------------------------------------------------------------------------------------------------------------------------------------|----------------------------------------------------------------------------------------------------------------------------------------------------------------------------------------------------------------------------------|

Drawing Title: **THQ NOWSHERA VIRKAN  
CLINICAL BLOCK PLAN (PART**

# CLINICAL BLOCK OF THQ HOSPITAL NOWSHERA VIRKAN

## FIRST FLOOR

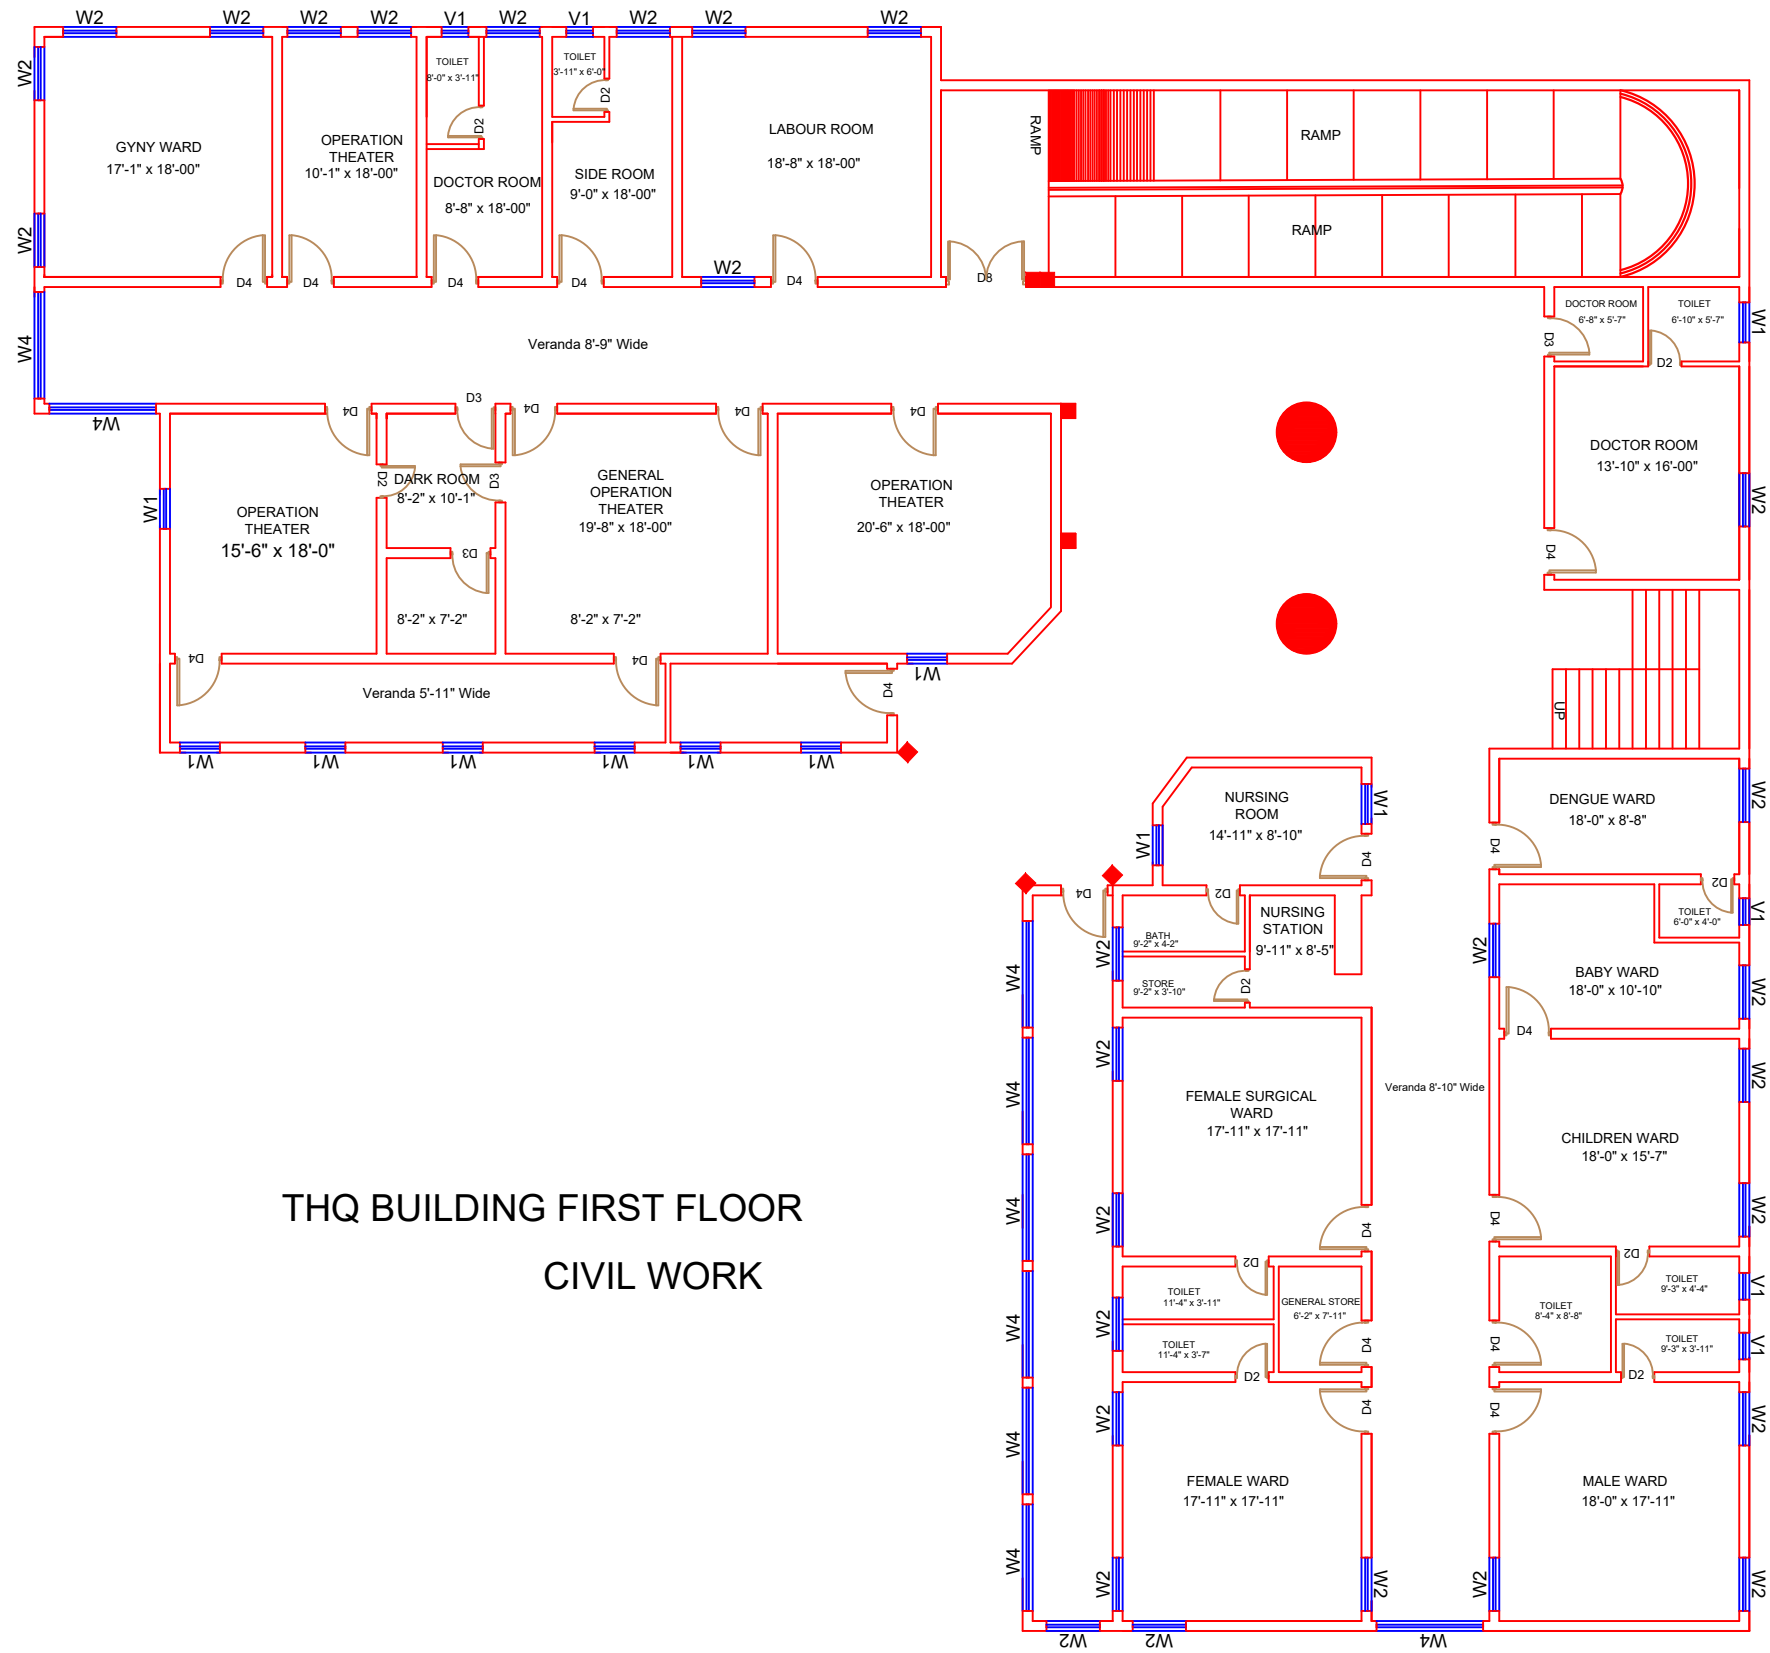

THQ BUILDING FIRST FLOOR  
CIVIL WORK

| Legends:                  |  |
|---------------------------|--|
| Residential Area          |  |
| Road                      |  |
| Wall                      |  |
| Power Line                |  |
| OHT                       |  |
| Tree                      |  |
| Man Hole                  |  |
| Tube Well                 |  |
| Light Pole                |  |
| Lawns                     |  |
| Earthen Areas             |  |
| Asphalts Roads            |  |
| Tough Pavers              |  |
| P.C.C / Plinth Protection |  |
| Boundary Wall             |  |
| Brick Pavers / Soling     |  |
| Drain                     |  |
| Tap                       |  |
| Hand Pump                 |  |
| Air Conditioner           |  |
| Tube Light                |  |
| Fan                       |  |
| Roof Light                |  |
| Bulb                      |  |

| AREA                      |              |
|---------------------------|--------------|
| AREA WITHIN BOUNDARY WALL | 97299.94 Sft |
| AREA OF CLINICAL BLOCK    | 21692.06 Sft |
| PLINTH AREA OF BLOCK      | 11681.95 Sft |

| OPENING SCHEDULE OF DOORS AND WINDOWS |       |        |         |       |        |
|---------------------------------------|-------|--------|---------|-------|--------|
| DOORS                                 | WIDTH | HEIGHT | WINDOWS | WIDTH | HEIGHT |
| D2                                    | 2'-6" | 7'-0"  | W1      | 3'-0" | 3'-0"  |
| D3                                    | 3'-0" | 7'-0"  | W2      | 4'-0" | 4'-0"  |
| D4                                    | 3'-6" | 7'-0"  | W3      | 6'-0" | 6'-0"  |
| D5                                    | 4'-0" | 7'-0"  | W4      | 8'-0" | 8'-0"  |
| D6                                    | 4'-6" | 7'-0"  | V1      | 2'-0" | 2'-0"  |
| D7                                    | 5'-0" | 7'-0"  |         |       |        |
|                                       |       |        |         |       |        |
|                                       |       |        |         |       |        |
|                                       |       |        |         |       |        |


Project:  
**CAD MAPPING OF TEHSIL  
HEAD QUARTER HOSPITALS,  
PUNJAB**

|                                                                                         |                                                                                                    |
|-----------------------------------------------------------------------------------------|----------------------------------------------------------------------------------------------------|
| Client:<br><br>GOVERNMENT OF THE PUNJAB<br>PRIMARY & SECONDARY<br>HEALTHCARE DEPARTMENT | Consultant:<br><br>SKAFS CONSULTANT (Pvt.)<br>Limited<br>ENGINEERING AND ENVIRONMENT<br>CONSULTANT |
|-----------------------------------------------------------------------------------------|----------------------------------------------------------------------------------------------------|

Drawing Title:  
**THQ NOWSHERA VIRKAN  
FIRST FLOOR PLAN**

Drawing No.  
**SKAFS/NOWSHERA.VK /13**

# ELECTRICAL LAYOUT PLAN OF THQ HOSPITAL NOWSHERA VIRKAN GROUND FLOOR

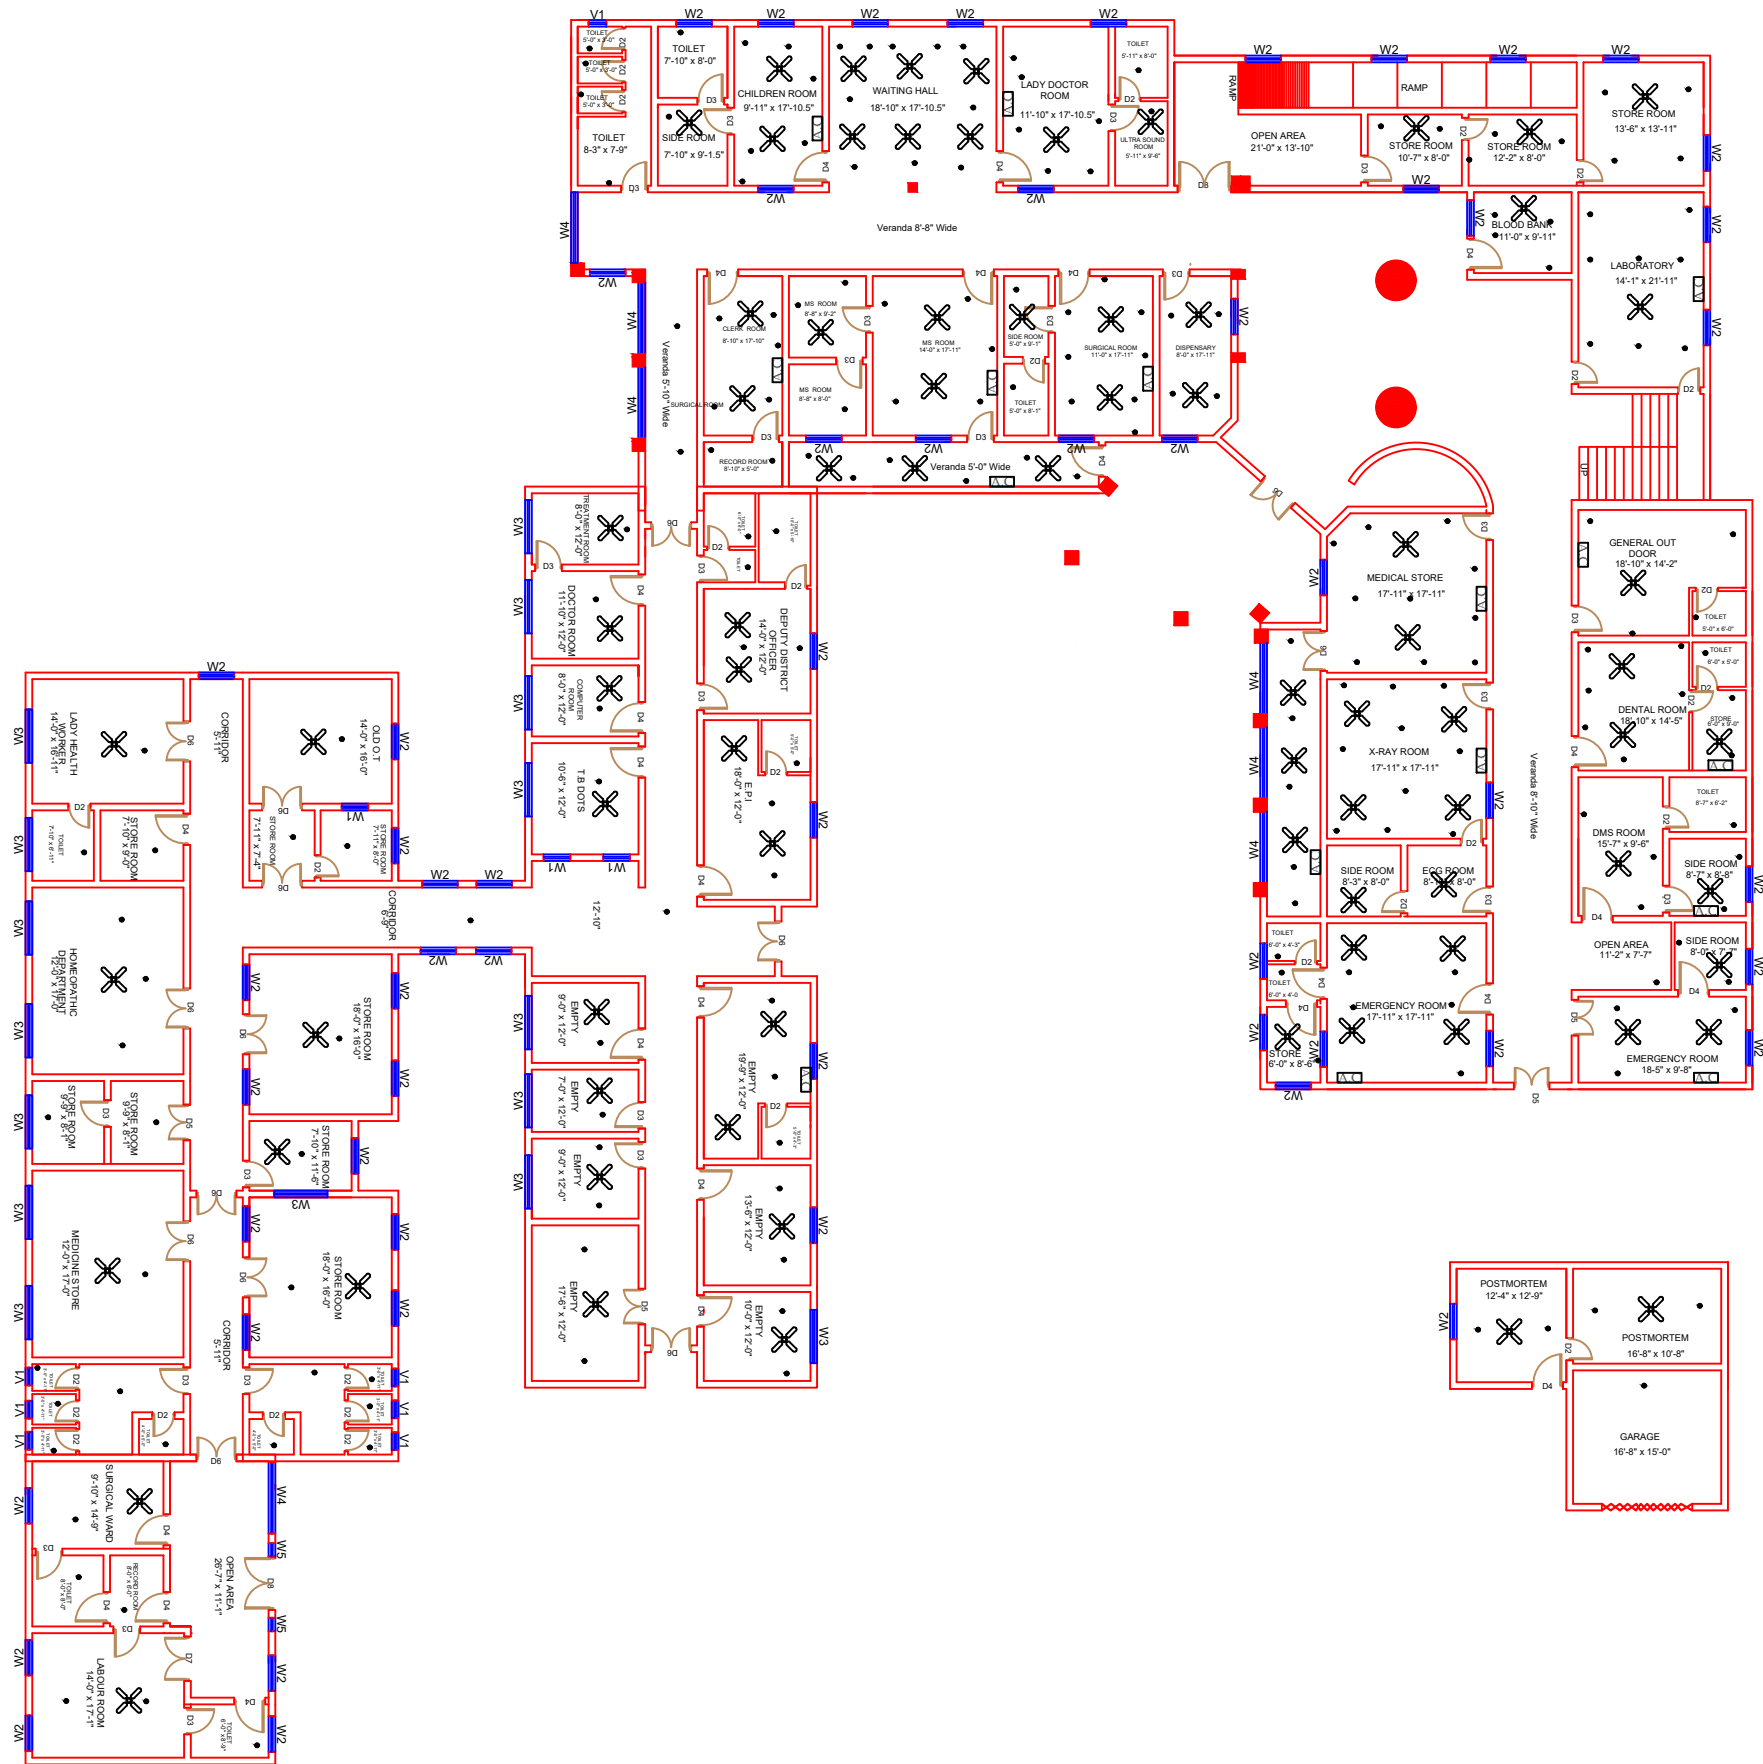

**Legends:**

|                           |  |
|---------------------------|--|
| Residential Area          |  |
| Road                      |  |
| Wall                      |  |
| Power Line                |  |
| OHT                       |  |
| Tree                      |  |
| Man Hole                  |  |
| Tube Well                 |  |
| Light Pole                |  |
| Lawns                     |  |
| Earthen Areas             |  |
| Asphalts Roads            |  |
| Tough Pavers              |  |
| P.C.C / Plinth Protection |  |
| Boundary Wall             |  |
| Brick Pavers / Soling     |  |
| Drain                     |  |
| Tap                       |  |
| Hand Pump                 |  |
| Air Conditioner           |  |
| Tube Light                |  |
| Fan                       |  |
| Roof Light                |  |
| Bulb                      |  |

| AREA                      |  |              |  |  |  |
|---------------------------|--|--------------|--|--|--|
| AREA WITHIN BOUNDARY WALL |  | 97299.94 Sft |  |  |  |
| AREA OF CLINICAL BLOCK    |  | 21692.06 Sft |  |  |  |
| PLINTH AREA OF BLOCK      |  | 11681.95 Sft |  |  |  |

| OPENING SCHEDULE OF DOORS AND WINDOWS |       |        |         |       |        |
|---------------------------------------|-------|--------|---------|-------|--------|
| DOORS                                 | WIDTH | HEIGHT | WINDOWS | WIDTH | HEIGHT |
| D2                                    | 2'-6" | 7'-0"  | W1      | 3'-0" | 3'-0"  |
| D3                                    | 3'-0" | 7'-0"  | W2      | 4'-0" | 4'-0"  |
| D4                                    | 3'-6" | 7'-0"  | W3      | 6'-0" | 6'-0"  |
| D5                                    | 4'-0" | 7'-0"  | W4      | 8'-0" | 8'-0"  |
| D6                                    | 4'-6" | 7'-0"  | V1      | 2'-0" | 2'-0"  |
| D7                                    | 5'-0" | 7'-0"  |         |       |        |
|                                       |       |        |         |       |        |
|                                       |       |        |         |       |        |

Project:  
**CAD MAPPING OF TEHSIL  
HEAD QUARTER HOSPITALS,  
PUNJAB**

Client:  
  
GOVERNMENT OF THE PUNJAB  
PRIMARY & SECONDARY  
HEALTHCARE DEPARTMENT


Consultant:  
  
SKAFS CONSULTANT (Pvt.)  
Limited  
ENGINEERING AND ENVIRONMENT  
CONSULTANT

Drawing Title:  
**THQ NOWSHERA VIRKAN  
ELECTRICAL PLAN (GROUND FLOOR)**

Drawing No.  
**SKAFS/NOWSHERA.VK /14**



# ELECTRICAL LAYOUT PLAN OF THQ HOSPITAL NOWSHERAVIRKAN FIRST FLOOR

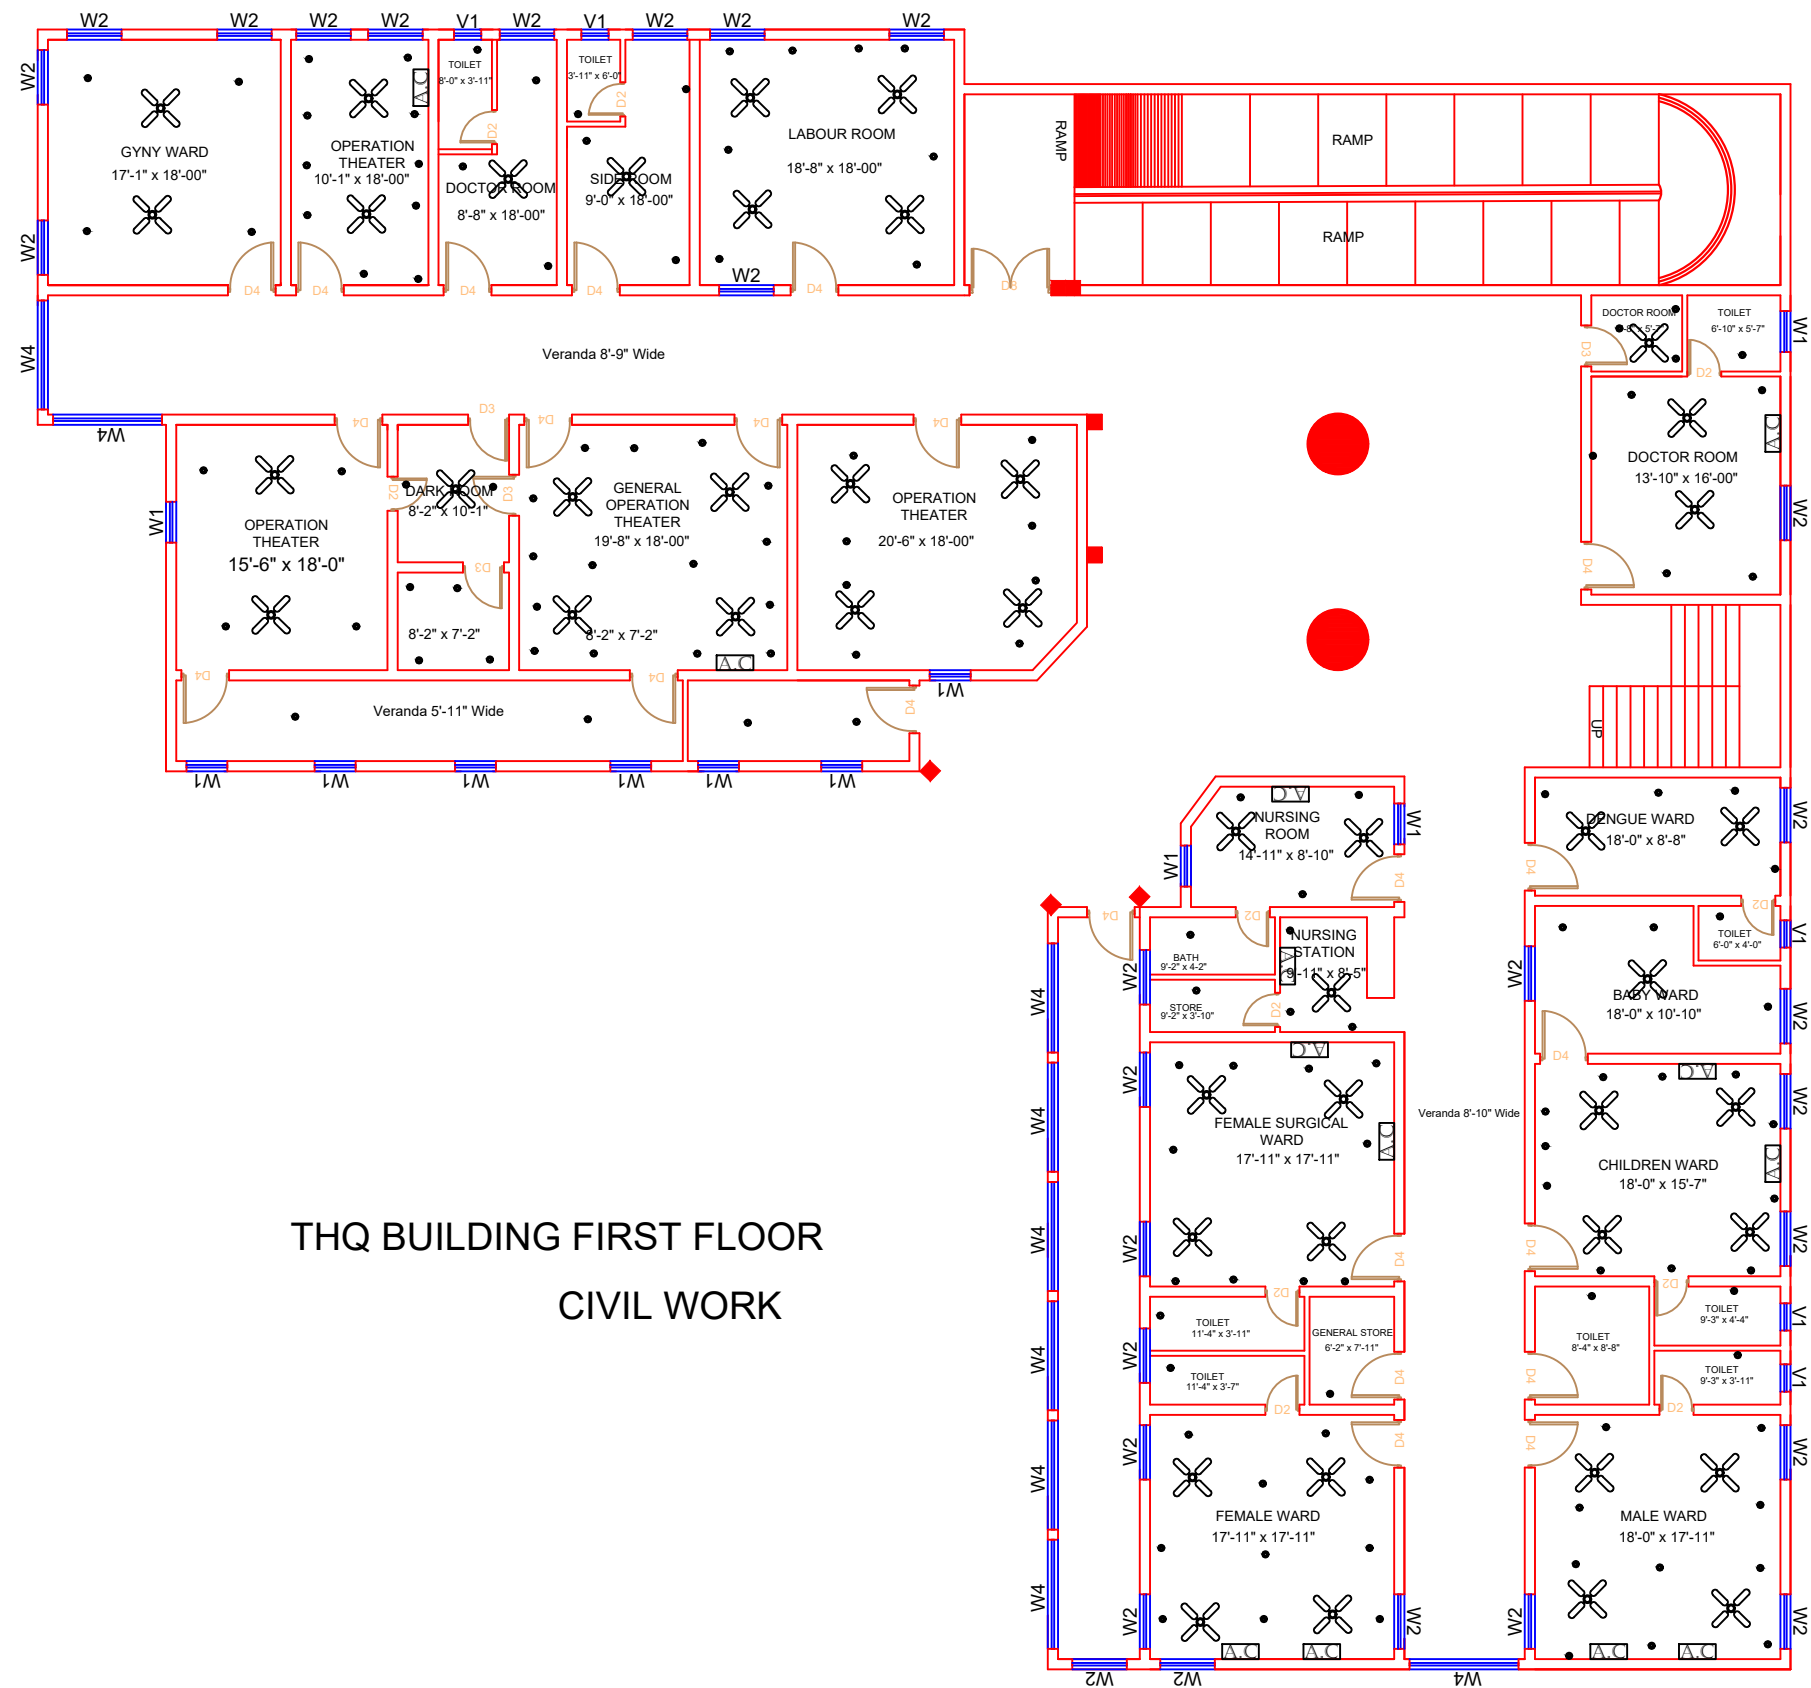

THQ BUILDING FIRST FLOOR  
CIVIL WORK

**Legends:**

|                           |  |
|---------------------------|--|
| Residential Area          |  |
| Road                      |  |
| Wall                      |  |
| Power Line                |  |
| OHT                       |  |
| Tree                      |  |
| Man Hole                  |  |
| Tube Well                 |  |
| Light Pole                |  |
| Lawns                     |  |
| Earthen Areas             |  |
| Asphalts Roads            |  |
| Tough Pavers              |  |
| P.C.C / Plinth Protection |  |
| Boundary Wall             |  |
| Brick Pavers / Soling     |  |
| Drain                     |  |
| Tap                       |  |
| Hand Pump                 |  |
| Air Conditioner           |  |
| Tube Light                |  |
| Fan                       |  |
| Roof Light                |  |
| Bulb                      |  |

| AREA                      |              |
|---------------------------|--------------|
| AREA WITHIN BOUNDARY WALL | 97299.94 Sft |
| AREA OF CLINICAL BLOCK    | 21692.06 Sft |
| PLINTH AREA OF BLOCK      | 11681.95 Sft |

| OPENING SCHEDULE OF DOORS AND WINDOWS |       |        |         |       |        |
|---------------------------------------|-------|--------|---------|-------|--------|
| DOORS                                 | WIDTH | HEIGHT | WINDOWS | WIDTH | HEIGHT |
| D2                                    | 2'-6" | 7'-0"  | W1      | 3'-0" | 3'-0"  |
| D3                                    | 3'-0" | 7'-0"  | W2      | 4'-0" | 4'-0"  |
| D4                                    | 3'-6" | 7'-0"  | W3      | 6'-0" | 6'-0"  |
| D5                                    | 4'-0" | 7'-0"  | W4      | 8'-0" | 8'-0"  |
| D6                                    | 4'-6" | 7'-0"  | V1      | 2'-0" | 2'-0"  |
| D7                                    | 5'-0" | 7'-0"  |         |       |        |
|                                       |       |        |         |       |        |
|                                       |       |        |         |       |        |
|                                       |       |        |         |       |        |

Project:  
**CAD MAPPING OF TEHSIL  
HEAD QUARTER HOSPITALS,  
PUNJAB**

Client:  
  
GOVERNMENT OF THE PUNJAB  
PRIMARY & SECONDARY  
HEALTHCARE DEPARTMENT

Consultant:  
  
SKAFS CONSULTANT (Pvt.)  
Limited  
ENGINEERING AND ENVIRONMENT  
CONSULTANT

Drawing Title:  
**THQ NOWSHERA VIRKAN  
ELECTRICAL PLAN (FIRST FLOOR)**

Drawing No.  
**SKAFS/NOWSHERA.VK /15**