



MASTER PLAN OF THQ HOSPITAL PIND DADEN KHAN

PART 1

PART 2

PART 3

PART 4

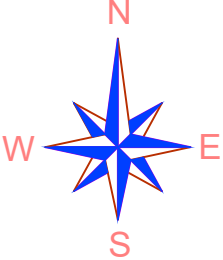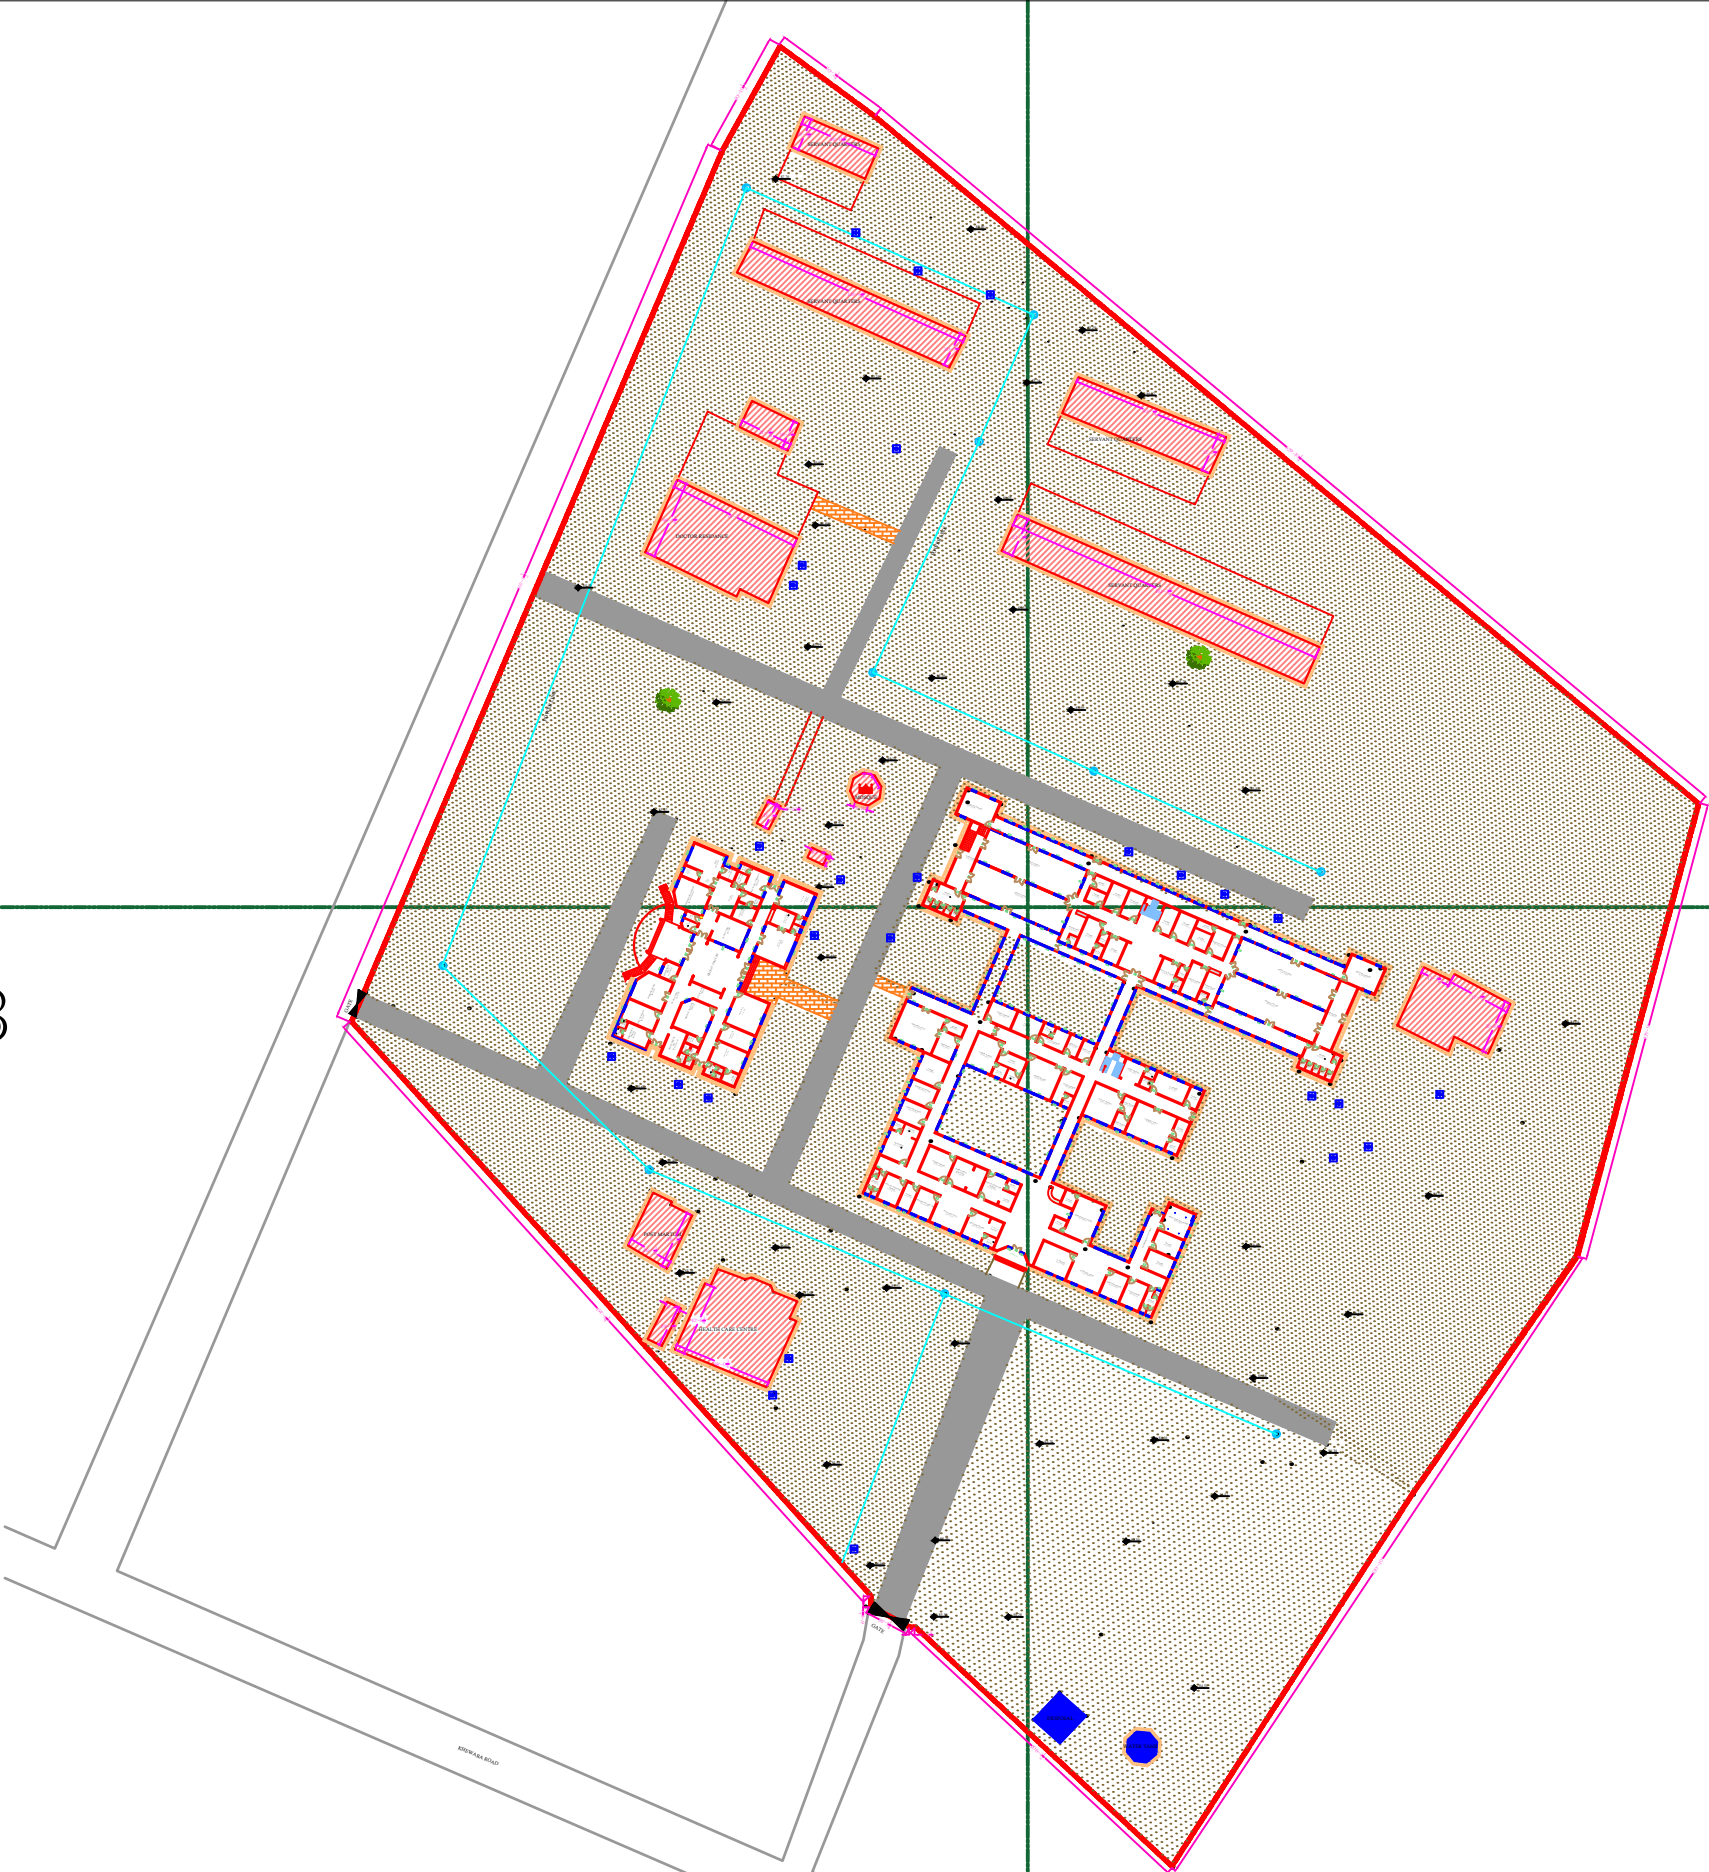

LEGENDS:

RESIDENTIAL AREA	
ROAD	
WALL	
POWER LINE	
OHT	
TREE	
MAN HOLE	
TUBE WELL	
LIGHT POLE	
LAWNS	
EARTHEN AREAS	
ASPHALTS ROADS	
TOUGH PAVERS	
P.C.C / PLINTH PROTECTION	
BOUNDARY WALL	
BRICK PAVERS / SOLING	
DRAIN	
TAP	
HAND PUMP	
AIR CONDITIONER	
TUBE LIGHT	
FAN	
ROOF LIGHT	
BULB	

AREA	
AREA WITHIN BOUNDARY WALL	465338.09 SFT
AREA OF CLINICAL BLOCK	43854.59 SFT
PLINTH AREA OF BLOCK	43854.59 SFT


OPENING SCHEDULE OF DOORS AND WINDOWS					
DOORS	WIDTH	HEIGHT	WINDOWS	WIDTH	HEIGHT
D1	5'-0"	7'-0"	W1	3'-0"	5'-0"
D2	4'-0"	7'-0"	W2	3'-6"	5'-0"
D3	3'-6"	7'-0"	W3	6'-0"	5'-0"
D4	3'-0"	7'-0"	W4	4'-6"	5'-0"
D5	2'-6"	7'-0"	W5	8'-0"	5'-0"
D6	6'-0"	7'-0"	W6	12'-0"	5'-0"
VENTS	WIDTH	HEIGHT	W7	2'-6"	5'-0"
V1	1'-6"	2'-0"	W8	4'-0"	5'-0"
V2	2'-0"	2'-0"	W9	5'-0"	5'-0"
V3	3'-0"	2'-0"	W0	2'-0"	5'-0"

Project:
**CAD MAPPING OF TEHSIL
HEAD QUARTER HOSPITALS,
PUNJAB**

Client: GOVERNMENT OF THE PUNJAB PRIMARY & SECONDARY HEALTHCARE DEPARTMENT	Consultant: SKAFS CONSULTANT (Pvt.) Limited ENGINEERING AND ENVIRONMENT CONSULTANT
---	--


Drawing Title:
**THQ PIND DADEN KHAN
HOSPITAL MASTER PLAN**

Drawing No.
SKAFS/PIND DADEN KHAN/03

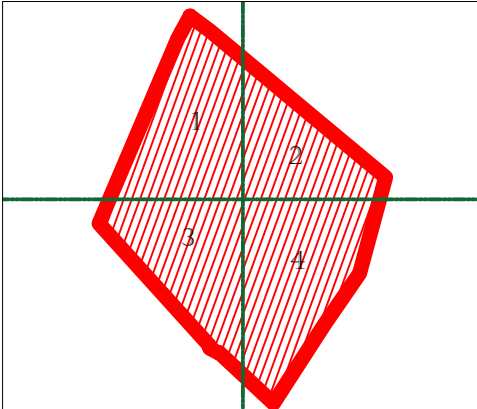

MASTER PLAN OF THQ HOSPITAL PIND DADEN KHAN

PART 1

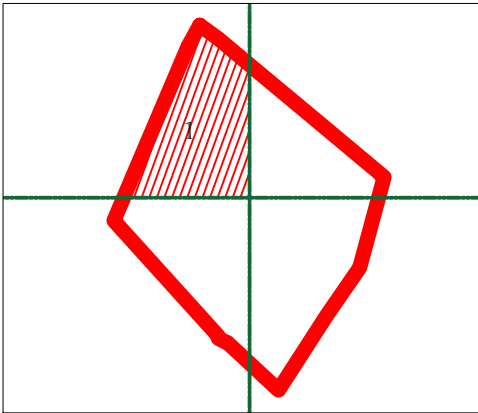

LEGENDS:

RESIDENTIAL AREA	
ROAD	
WALL	
POWER LINE	
OHT	
TREE	
MAN HOLE	
TUBE WELL	
LIGHT POLE	
LAWNS	
EARTHEN AREAS	
ASPHALTS ROADS	
TOUGH PAVERS	
P.C.C / PLINTH PROTECTION	
BOUNDARY WALL	
BRICK PAVERS / SOLING	
DRAIN	
TAP	
HAND PUMP	
AIR CONDITIONER	
TUBE LIGHT	
FAN	
ROOF LIGHT	
BULB	

AREA	
AREA WITHIN BOUNDARY WALL	465338.09 SFT
AREA OF CLINICAL BLOCK	43854.59 SFT
PLINTH AREA OF BLOCK	43854.59 SFT

OPENING SCHEDULE OF DOORS AND WINDOWS					
DOORS	WIDTH	HEIGHT	WINDOWS	WIDTH	HEIGHT
D1	5'-0"	7'-0"	W1	3'-0"	5'-0"
D2	4'-0"	7'-0"	W2	3'-6"	5'-0"
D3	3'-6"	7'-0"	W3	6'-0"	5'-0"
D4	3'-0"	7'-0"	W4	4'-6"	5'-0"
D5	2'-6"	7'-0"	W5	8'-0"	5'-0"
D6	6'-0"	7'-0"	W6	12'-0"	5'-0"
VENTS	WIDTH	HEIGHT	W7	2'-6"	5'-0"
V1	1'-6"	2'-0"	W8	4'-0"	5'-0"
V2	2'-0"	2'-0"	W9	5'-0"	5'-0"
V3	3'-0"	2'-0"	W0	2'-0"	5'-0"

Project:
**CAD MAPPING OF TEHSIL
HEAD QUARTER HOSPITALS,
PUNJAB**

Client:

GOVERNMENT OF THE PUNJAB
PRIMARY & SECONDARY
HEALTHCARE DEPARTMENT

Consultant:



SKAFS CONSULTANT (Pvt.)
Limited
ENGINEERING AND ENVIRONMENT
CONSULTANT

Drawing Title:
**THQ PIND DADEN KHAN
HOSPITAL MASTER PLAN PART 1**

Drawing No.
SKAFS/PIND DADEN KHAN/04

MASTER PLAN OF THQ HOSPITAL PIND DADEN KHAN

PART 2

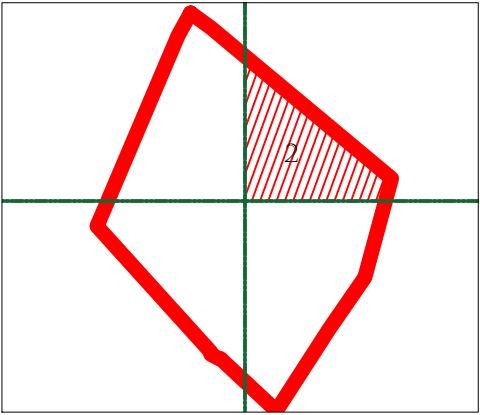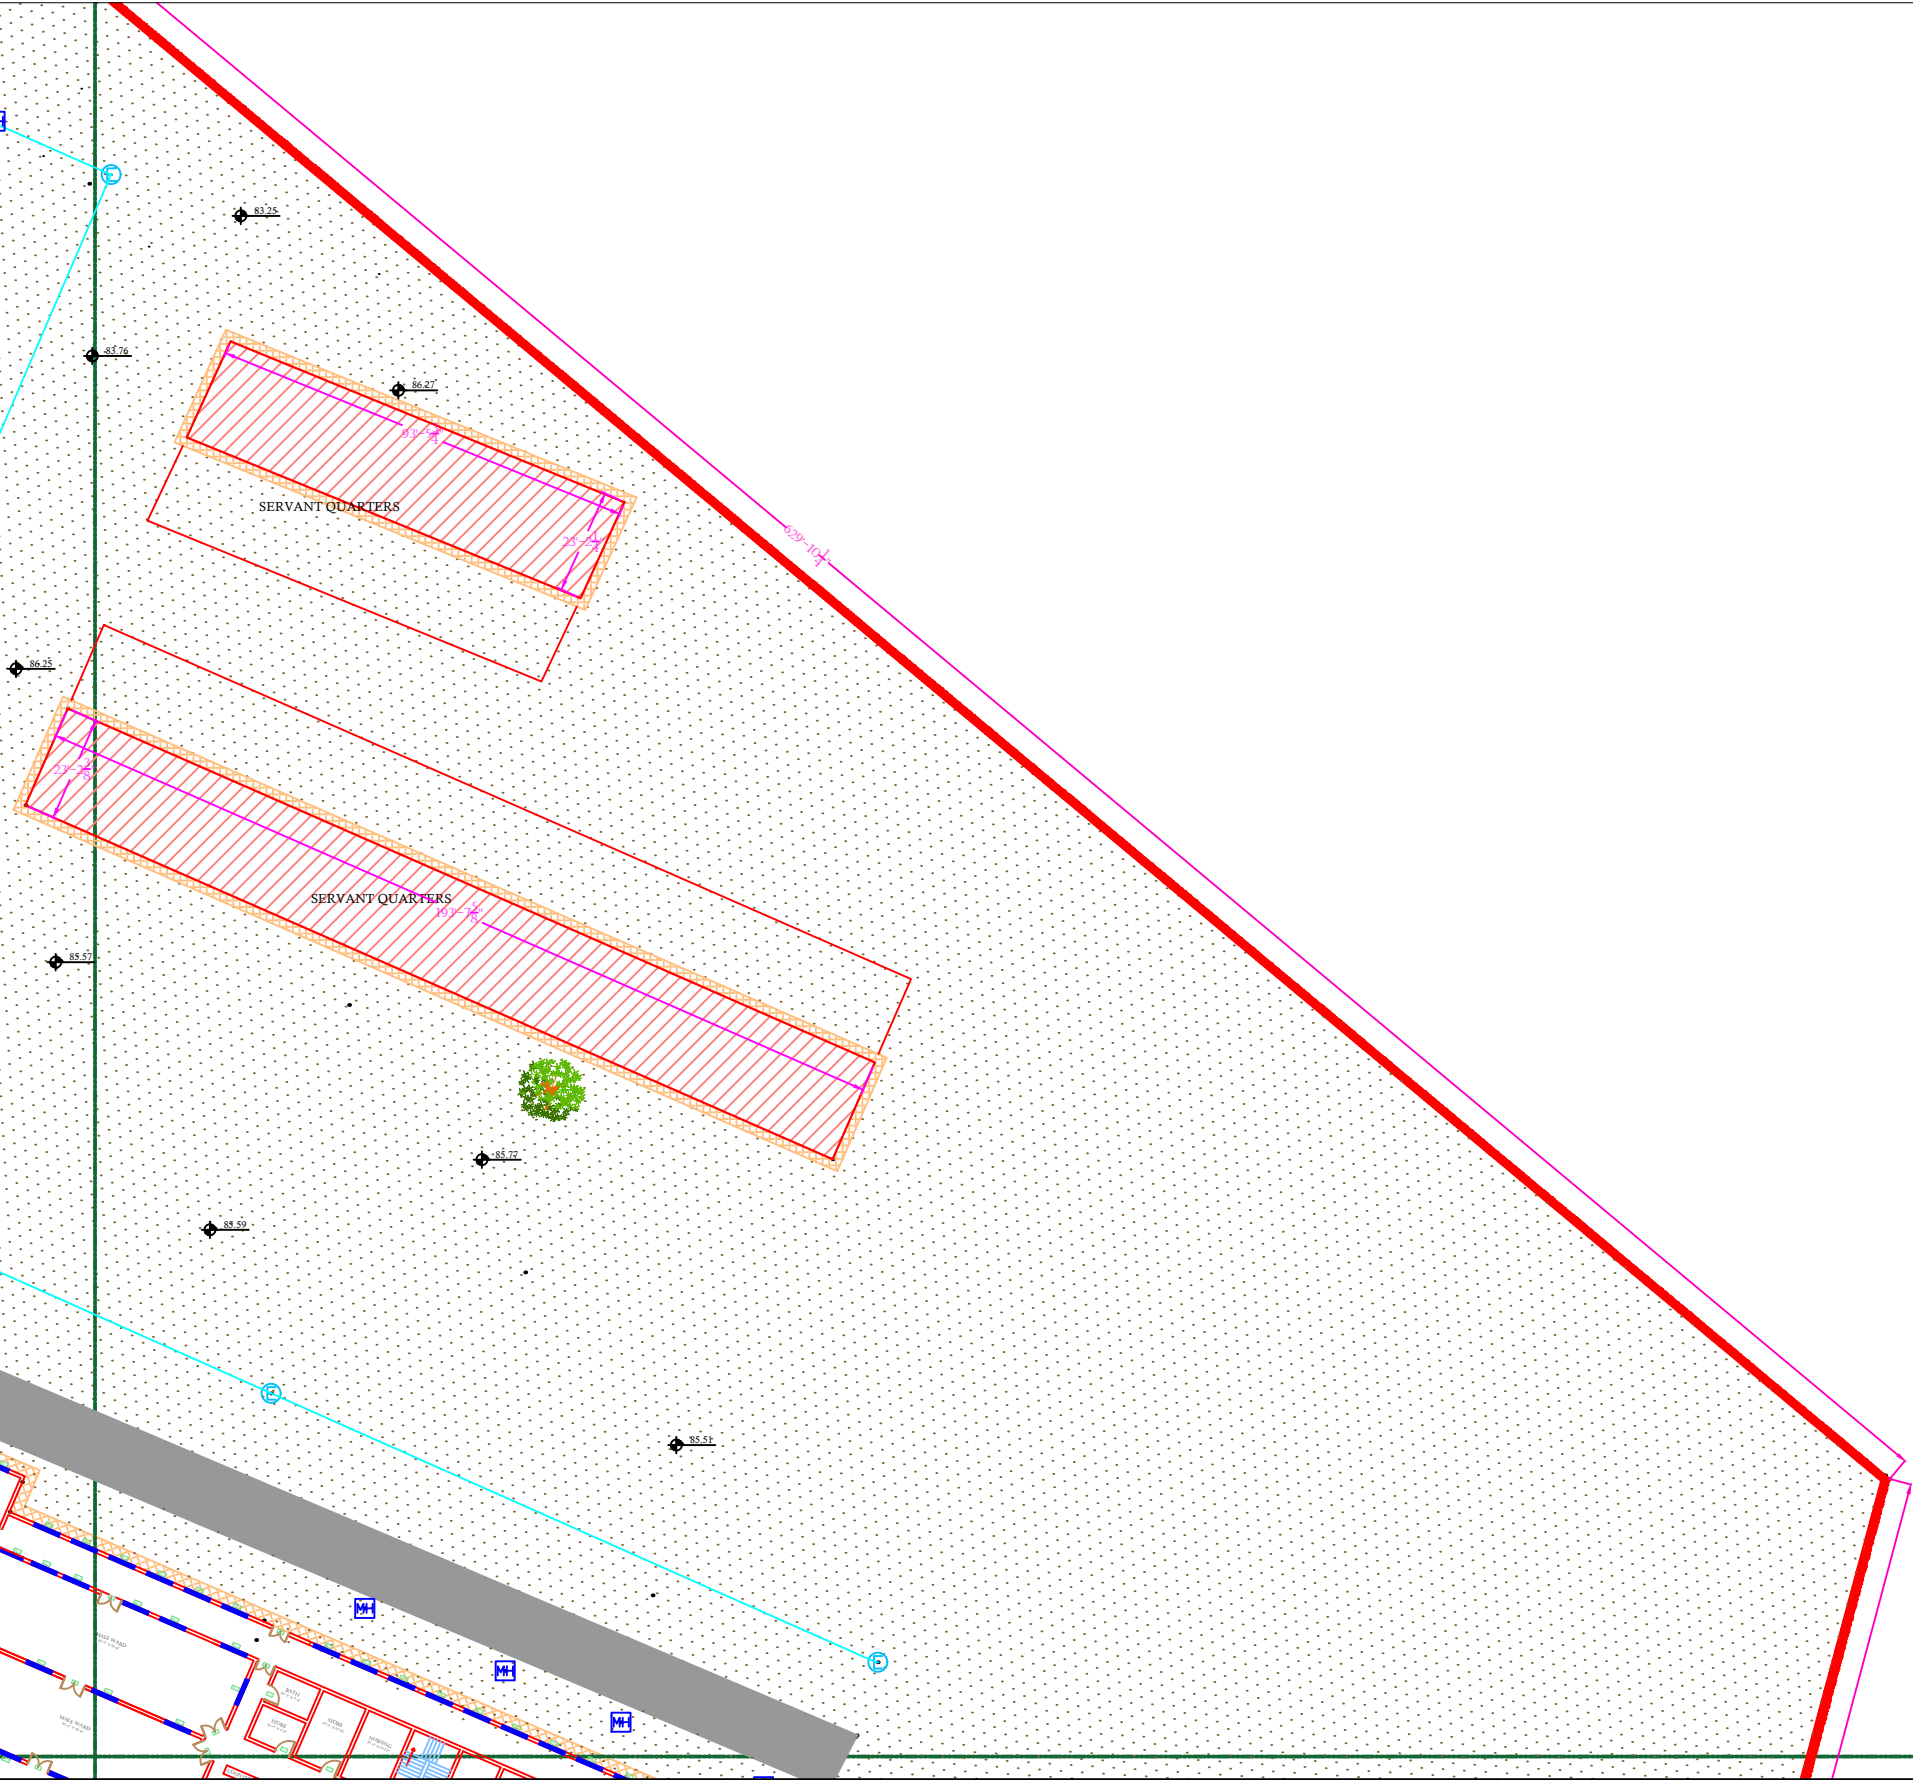

LEGENDS:	
RESIDENTIAL AREA	
ROAD	
WALL	
POWER LINE	
OHT	
TREE	
MAN HOLE	
TUBE WELL	
LIGHT POLE	
LAWNS	
EARTHEN AREAS	
ASPHALTS ROADS	
TOUGH PAVERS	
P.C.C / PLINTH PROTECTION	
BOUNDARY WALL	
BRICK PAVERS / SOLING	
DRAIN	
TAP	
HAND PUMP	
AIR CONDITIONER	
TUBE LIGHT	
FAN	
ROOF LIGHT	
BULB	

AREA	
AREA WITHIN BOUNDARY WALL	465338.09 SFT
AREA OF CLINICAL BLOCK	43854.59 SFT
PLINTH AREA OF BLOCK	43854.59 SFT

OPENING SCHEDULE OF DOORS AND WINDOWS					
DOORS	WIDTH	HEIGHT	WINDOWS	WIDTH	HEIGHT
D1	5'-0"	7'-0"	W1	3'-0"	5'-0"
D2	4'-0"	7'-0"	W2	3'-6"	5'-0"
D3	3'-6"	7'-0"	W3	6'-0"	5'-0"
D4	3'-0"	7'-0"	W4	4'-6"	5'-0"
D5	2'-6"	7'-0"	W5	8'-0"	5'-0"
D6	6'-0"	7'-0"	W6	12'-0"	5'-0"
VENTS	WIDTH	HEIGHT	W7	2'-6"	5'-0"
V1	1'-6"	2'-0"	W8	4'-0"	5'-0"
V2	2'-0"	2'-0"	W9	5'-0"	5'-0"
V3	3'-0"	2'-0"	W0	2'-0"	5'-0"

Project:
**CAD MAPPING OF TEHSIL
HEAD QUARTER HOSPITALS,
PUNJAB**



Client: GOVERNMENT OF THE PUNJAB PRIMARY & SECONDARY HEALTHCARE DEPARTMENT	Consultant: SKAFS CONSULTANT (Pvt.) Limited ENGINEERING AND ENVIRONMENT CONSULTANT
---	--

Drawing Title:
**THQ PIND DADEN KHAN
HOSPITAL MASTER PLAN PART 2**

Drawing No.
SKAFS/PIND DADEN KHAN/05

MASTER PLAN OF THQ HOSPITAL PIND DADEN KHAN

PART 3

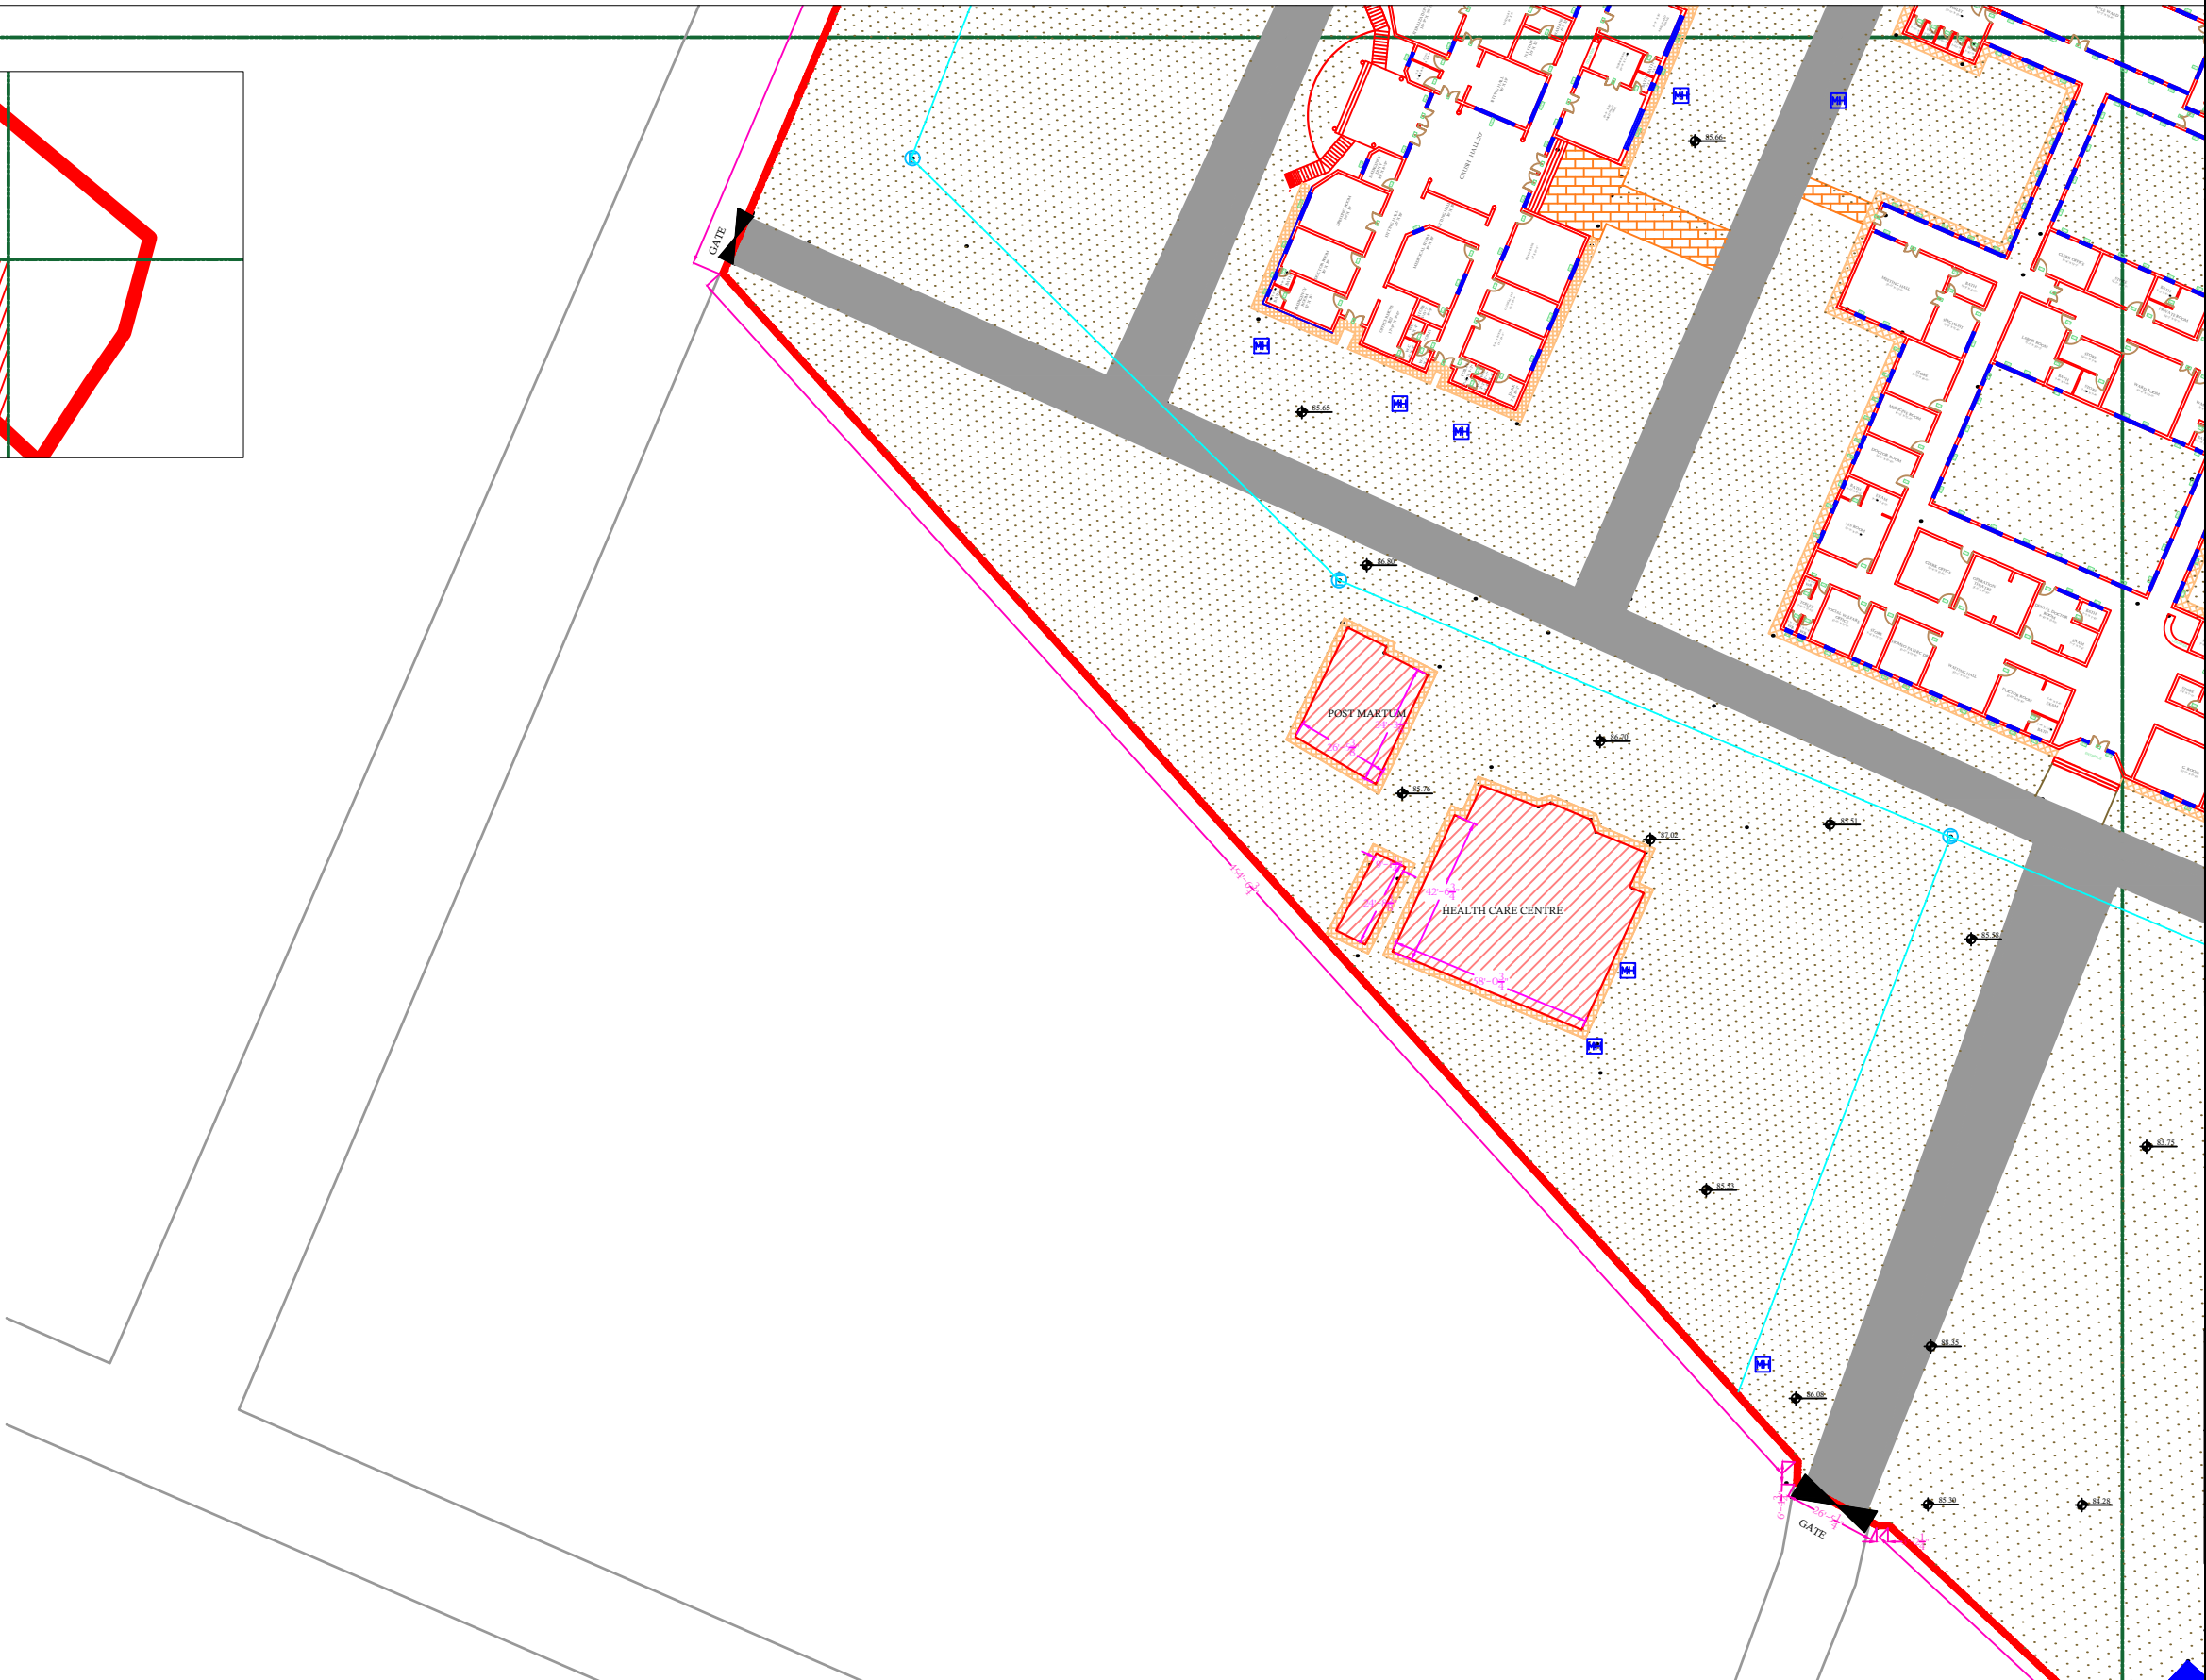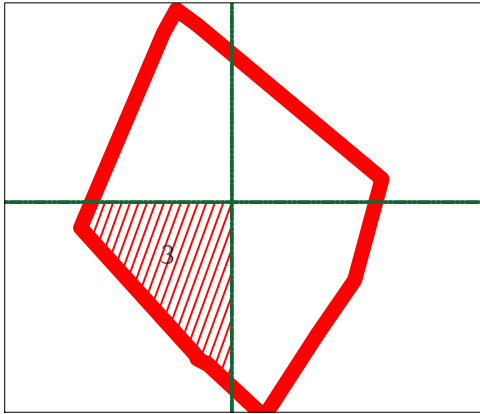

LEGENDS:

RESIDENTIAL AREA	
ROAD	
WALL	
POWER LINE	
OHT	
TREE	
MAN HOLE	
TUBE WELL	
LIGHT POLE	
LAWNS	
EARTHEN AREAS	
ASPHALTS ROADS	
TOUGH PAVERS	
P.C.C / PLINTH PROTECTION	
BOUNDARY WALL	
BRICK PAVERS / SOLING	
DRAIN	
TAP	
HAND PUMP	
AIR CONDITIONER	
TUBE LIGHT	
FAN	
ROOF LIGHT	
BULB	

AREA

AREA WITHIN BOUNDARY WALL	465338.09 SFT
AREA OF CLINICAL BLOCK	43854.59 SFT
PLINTH AREA OF BLOCK	43854.59 SFT

OPENING SCHEDULE OF DOORS AND WINDOWS

DOORS	WIDTH	HEIGHT	WINDOWS	WIDTH	HEIGHT
D1	5'-0"	7'-0"	W1	3'-0"	5'-0"
D2	4'-0"	7'-0"	W2	3'-6"	5'-0"
D3	3'-6"	7'-0"	W3	6'-0"	5'-0"
D4	3'-0"	7'-0"	W4	4'-6"	5'-0"
D5	2'-6"	7'-0"	W5	8'-0"	5'-0"
D6	6'-0"	7'-0"	W6	12'-0"	5'-0"
VENTS	WIDTH	HEIGHT	W7	2'-6"	5'-0"
V1	1'-6"	2'-0"	W8	4'-0"	5'-0"
V2	2'-0"	2'-0"	W9	5'-0"	5'-0"
V3	3'-0"	2'-0"	W0	2'-0"	5'-0"

Project:

CAD MAPPING OF TEHSIL HEAD QUARTER HOSPITALS, PUNJAB

Client:

GOVERNMENT OF THE PUNJAB
PRIMARY & SECONDARY
HEALTHCARE DEPARTMENT

Consultant:

SKAFS CONSULTANT (Pvt.)
Limited
ENGINEERING AND ENVIRONMENT
CONSULTANT

Drawing Title:



**THQ PIND DADEN KHAN
HOSPITAL MASTER PLAN PART 3**

Drawing No.

SKAFS/PIND DADEN KHAN/06

MASTER PLAN OF THQ HOSPITAL PIND DADEN KHAN

PART 4

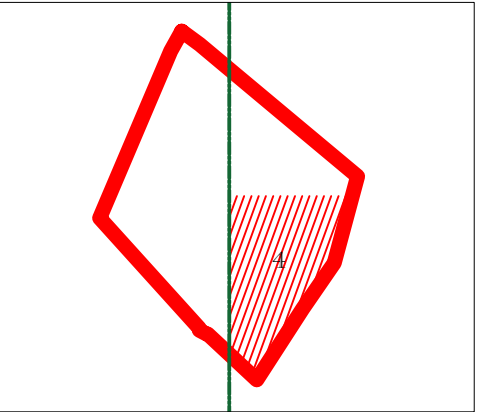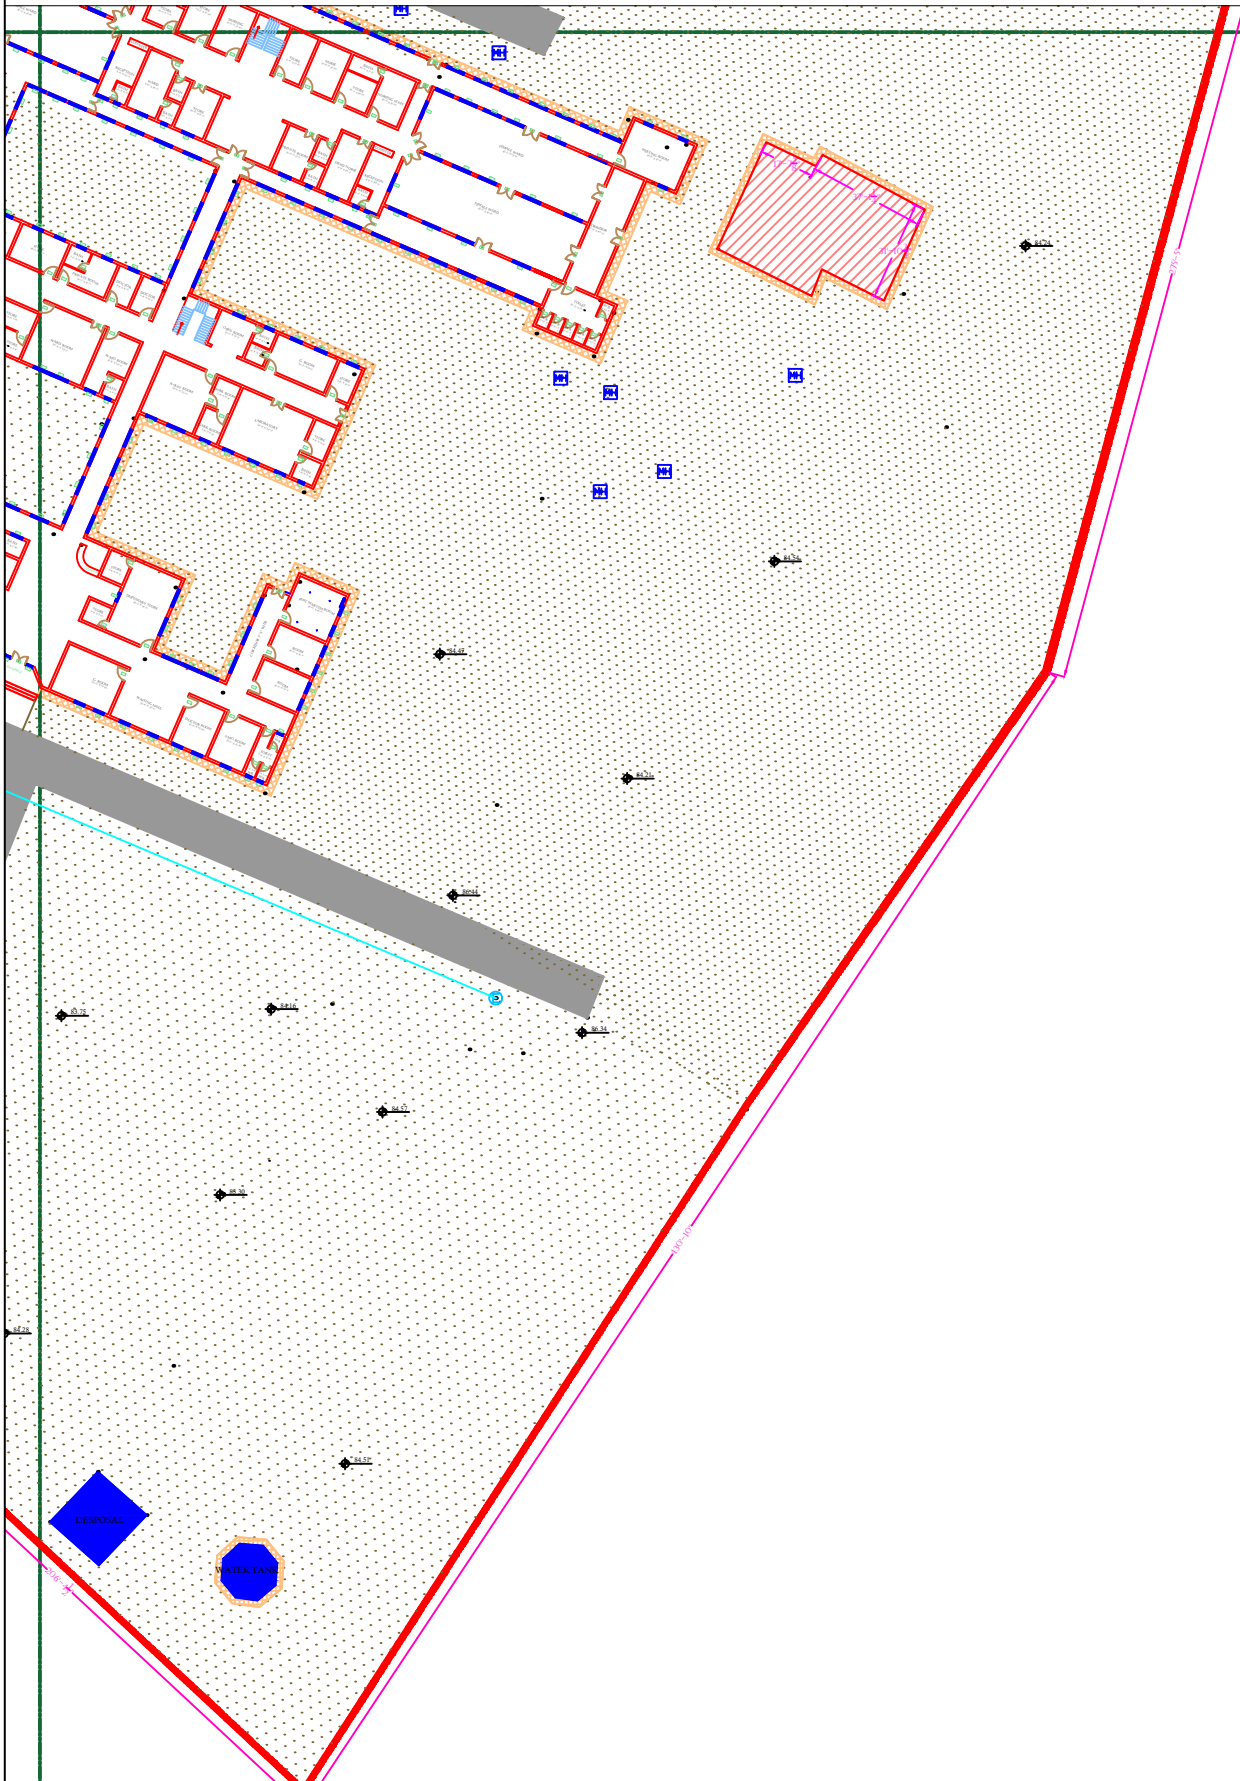

LEGENDS:	
RESIDENTIAL AREA	
ROAD	
WALL	
POWER LINE	
OHT	
TREE	
MAN HOLE	
TUBE WELL	
LIGHT POLE	
LAWNS	
EARTHEN AREAS	
ASPHALTS ROADS	
TOUGH PAVERS	
P.C.C / PLINTH PROTECTION	
BOUNDARY WALL	
BRICK PAVERS / SOLING	
DRAIN	
TAP	
HAND PUMP	
AIR CONDITIONER	
TUBE LIGHT	
FAN	
ROOF LIGHT	
BULB	

AREA	
AREA WITHIN BOUNDARY WALL	465338.09 SFT
AREA OF CLINICAL BLOCK	43854.59 SFT
PLINTH AREA OF BLOCK	43854.59 SFT

OPENING SCHEDULE OF DOORS AND WINDOWS					
DOORS	WIDTH	HEIGHT	WINDOWS	WIDTH	HEIGHT
D1	5'-0"	7'-0"	W1	3'-0"	5'-0"
D2	4'-0"	7'-0"	W2	3'-6"	5'-0"
D3	3'-6"	7'-0"	W3	6'-0"	5'-0"
D4	3'-0"	7'-0"	W4	4'-6"	5'-0"
D5	2'-6"	7'-0"	W5	8'-0"	5'-0"
D6	6'-0"	7'-0"	W6	12'-0"	5'-0"
VENTS	WIDTH	HEIGHT	W7	2'-6"	5'-0"
V1	1'-6"	2'-0"	W8	4'-0"	5'-0"
V2	2'-0"	2'-0"	W9	5'-0"	5'-0"
V3	3'-0"	2'-0"	W0	2'-0"	5'-0"

Project:
**CAD MAPPING OF TEHSIL
HEAD QUARTER HOSPITALS,
PUNJAB**

Client: GOVERNMENT OF THE PUNJAB PRIMARY & SECONDARY HEALTHCARE DEPARTMENT	Consultant: SKAFS CONSULTANT (Pvt.) Limited ENGINEERING AND ENVIRONMENT CONSULTANT
---	--


Drawing Title:
**THQ PIND DADEN KHAN
HOSPITAL MASTER PLAN PART 4**

Drawing No.
SKAFS/PIND DADEN KHAN/07


CLINICAL BLOCK OF THQ HOSPITAL PIND DADEN KHAN

GROUND FLOOR

PART 1

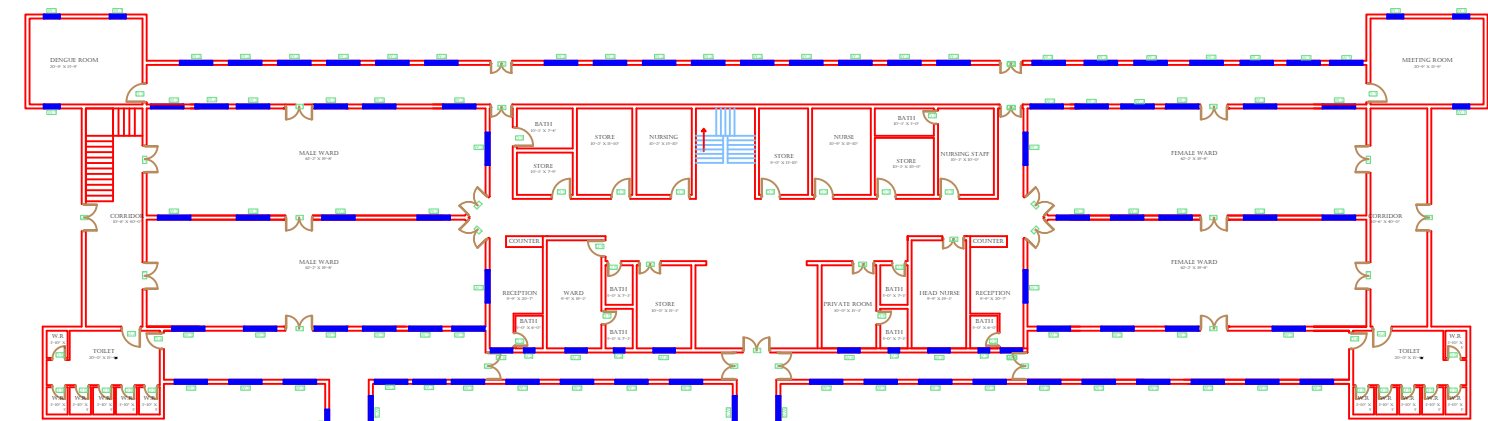

PART 2

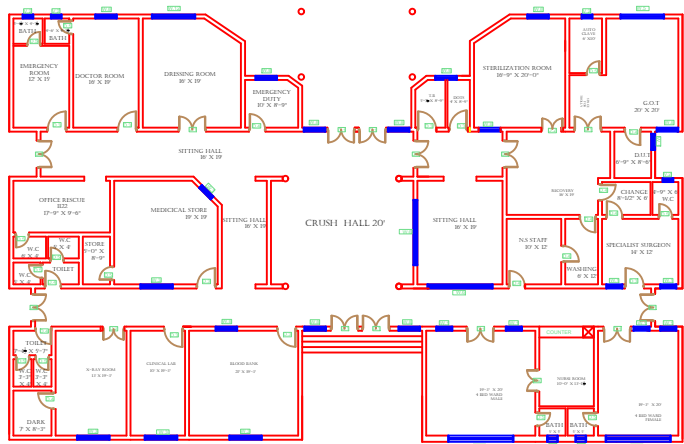

PART 3



LEGENDS:

RESIDENTIAL AREA

ROAD

WALL

POWER LINE

OHT

TREE

MAN HOLE

TUBE WELL

LIGHT POLE

LAWNS

EARTHEN AREAS

ASPHALTS ROADS

TOUGH PAVERS

P.C.C / PLINTH PROTECTION

BOUNDARY WALL

BRICK PAVERS / SOLING

DRAIN

TAP

HAND PUMP

AIR CONDITIONER

TUBE LIGHT

FAN

ROOF LIGHT

BULB

AREA	
AREA WITHIN BOUNDARY WALL	465338.09 SFT
AREA OF CLINICAL BLOCK	43854.59 SFT
PLINTH AREA OF BLOCK	43854.59 SFT

OPENING SCHEDULE OF DOORS AND WINDOWS					
DOORS	WIDTH	HEIGHT	WINDOWS	WIDTH	HEIGHT
D1	5'-0"	7'-0"	W1	3'-0"	5'-0"
D2	4'-0"	7'-0"	W2	3'-6"	5'-0"
D3	3'-6"	7'-0"	W3	6'-0"	5'-0"
D4	3'-0"	7'-0"	W4	4'-6"	5'-0"
D5	2'-6"	7'-0"	W5	8'-0"	5'-0"
D6	6'-0"	7'-0"	W6	12'-0"	5'-0"
VENTS	WIDTH	HEIGHT	W7	2'-6"	5'-0"
V1	1'-6"	2'-0"	W8	4'-0"	5'-0"
V2	2'-0"	2'-0"	W9	5'-0"	5'-0"
V3	3'-0"	2'-0"	W0	2'-0"	5'-0"

Project:

CAD MAPPING OF TEHSIL HEAD QUARTER HOSPITALS, PUNJAB

Client:

GOVERNMENT OF THE PUNJAB
PRIMARY & SECONDARY HEALTHCARE DEPARTMENT

Consultant:

SKAFS CONSULTANT (Pvt.) Limited
ENGINEERING AND ENVIRONMENT CONSULTANT


Drawing Title:

THQ PIND DADEN KHAN HOSPITAL CLINICAL BLOCK PLAN


Drawing No.

SKAFS/PIND DADEN KHAN/08

CLINICAL BLOCK OF THQ HOSPITAL PIND DADEN KHAN
GROUND FLOOR PART 1

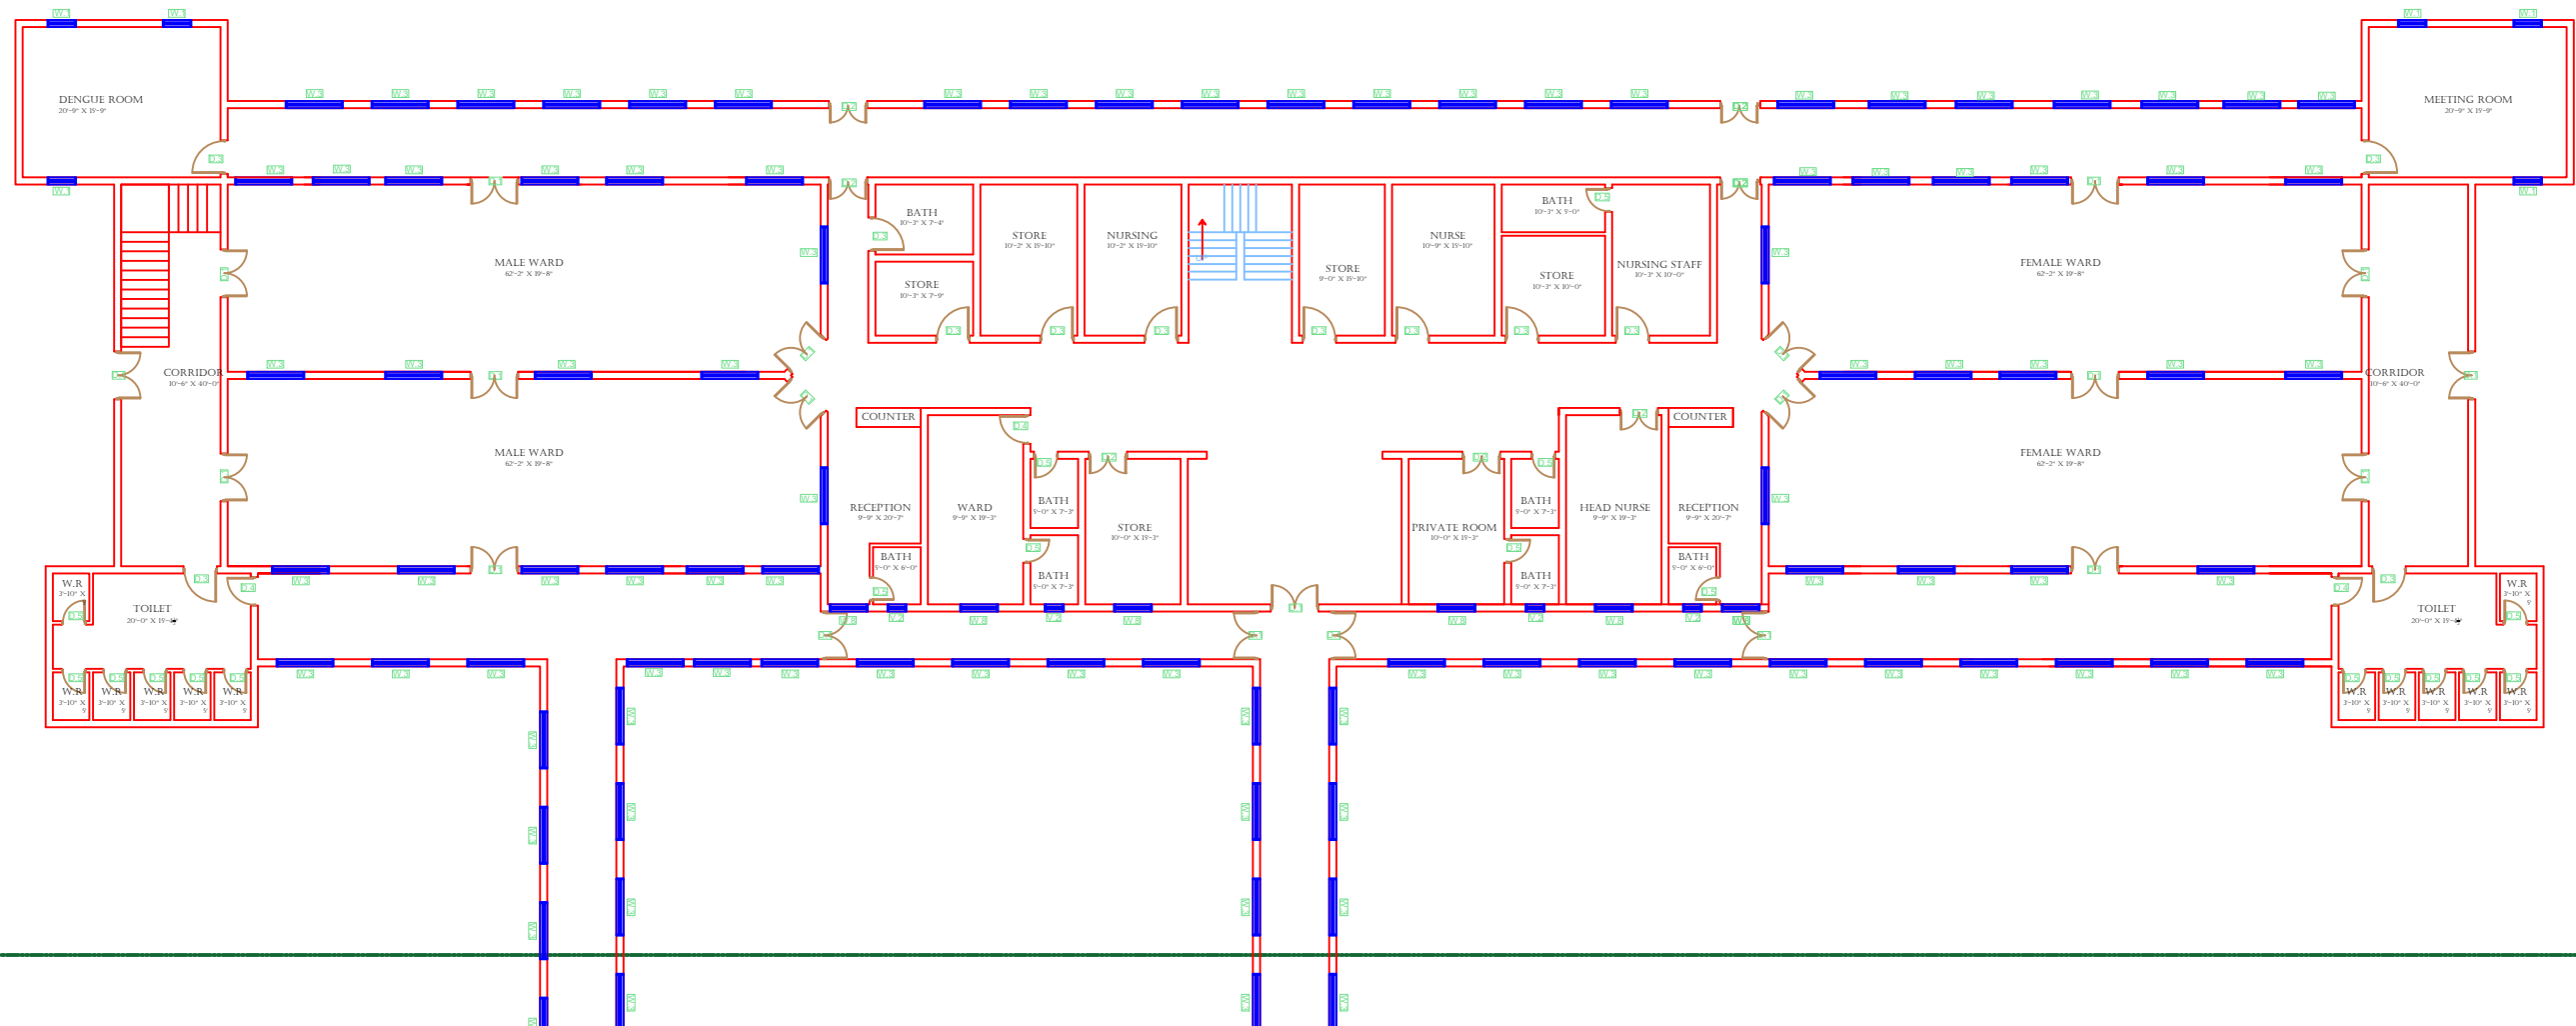

LEGENDS:

 RESIDENTIAL AREA	
ROAD	
WALL	
POWER LINE	
OHT	
TREE	
MAN HOLE	
TUBE WELL	
LIGHT POLE	
LAWNS	
EARTHEN AREAS	
ASPHALTS ROADS	
TOUGH PAVERS	
P.C.C / PLINTH PROTECTION	
BOUNDARY WALL	
BRICK PAVERS / SOLING	
DRAIN	
TAP	
HAND PUMP	
AIR CONDITIONER	
TUBE LIGHT	
FAN	
ROOF LIGHT	
BULB	

AREA	
AREA WITHIN BOUNDARY WALL	465338.09 SFT
AREA OF CLINICAL BLOCK	43854.59 SFT
PLINTH AREA OF BLOCK	43854.59 SFT

OPENING SCHEDULE OF DOORS AND WINDOWS					
DOORS	WIDTH	HEIGHT	WINDOWS	WIDTH	HEIGHT
D1	5'-0"	7'-0"	W1	3'-0"	5'-0"
D2	4'-0"	7'-0"	W2	3'-6"	5'-0"
D3	3'-6"	7'-0"	W3	6'-0"	5'-0"
D4	3'-0"	7'-0"	W4	4'-6"	5'-0"
D5	2'-6"	7'-0"	W5	8'-0"	5'-0"
D6	6'-0"	7'-0"	W6	12'-0"	5'-0"
VENTS	WIDTH	HEIGHT	W7	2'-6"	5'-0"
V1	1'-6"	2'-0"	W8	4'-0"	5'-0"
V2	2'-0"	2'-0"	W9	5'-0"	5'-0"
V3	3'-0"	2'-0"	W0	2'-0"	5'-0"

Project:
**CAD MAPPING OF TEHSIL
HEAD QUARTER HOSPITALS,
PUNJAB**


Client:  GOVERNMENT OF THE PUNJAB PRIMARY & SECONDARY HEALTHCARE DEPARTMENT	Consultant:  SKAFS CONSULTANT (Pvt.) Limited ENGINEERING AND ENVIRONMENT CONSULTANT
---	--

Drawing Title: **THQ PIND DADEN KHAN
CLINICAL BLOCK PLAN (PART 1)**

Drawing No. **SKAFS/PIND DADEN KHAN/09**

CLINICAL BLOCK OF THQ HOSPITAL PIND DADEN KHAN

GROUND FLOOR PART 2

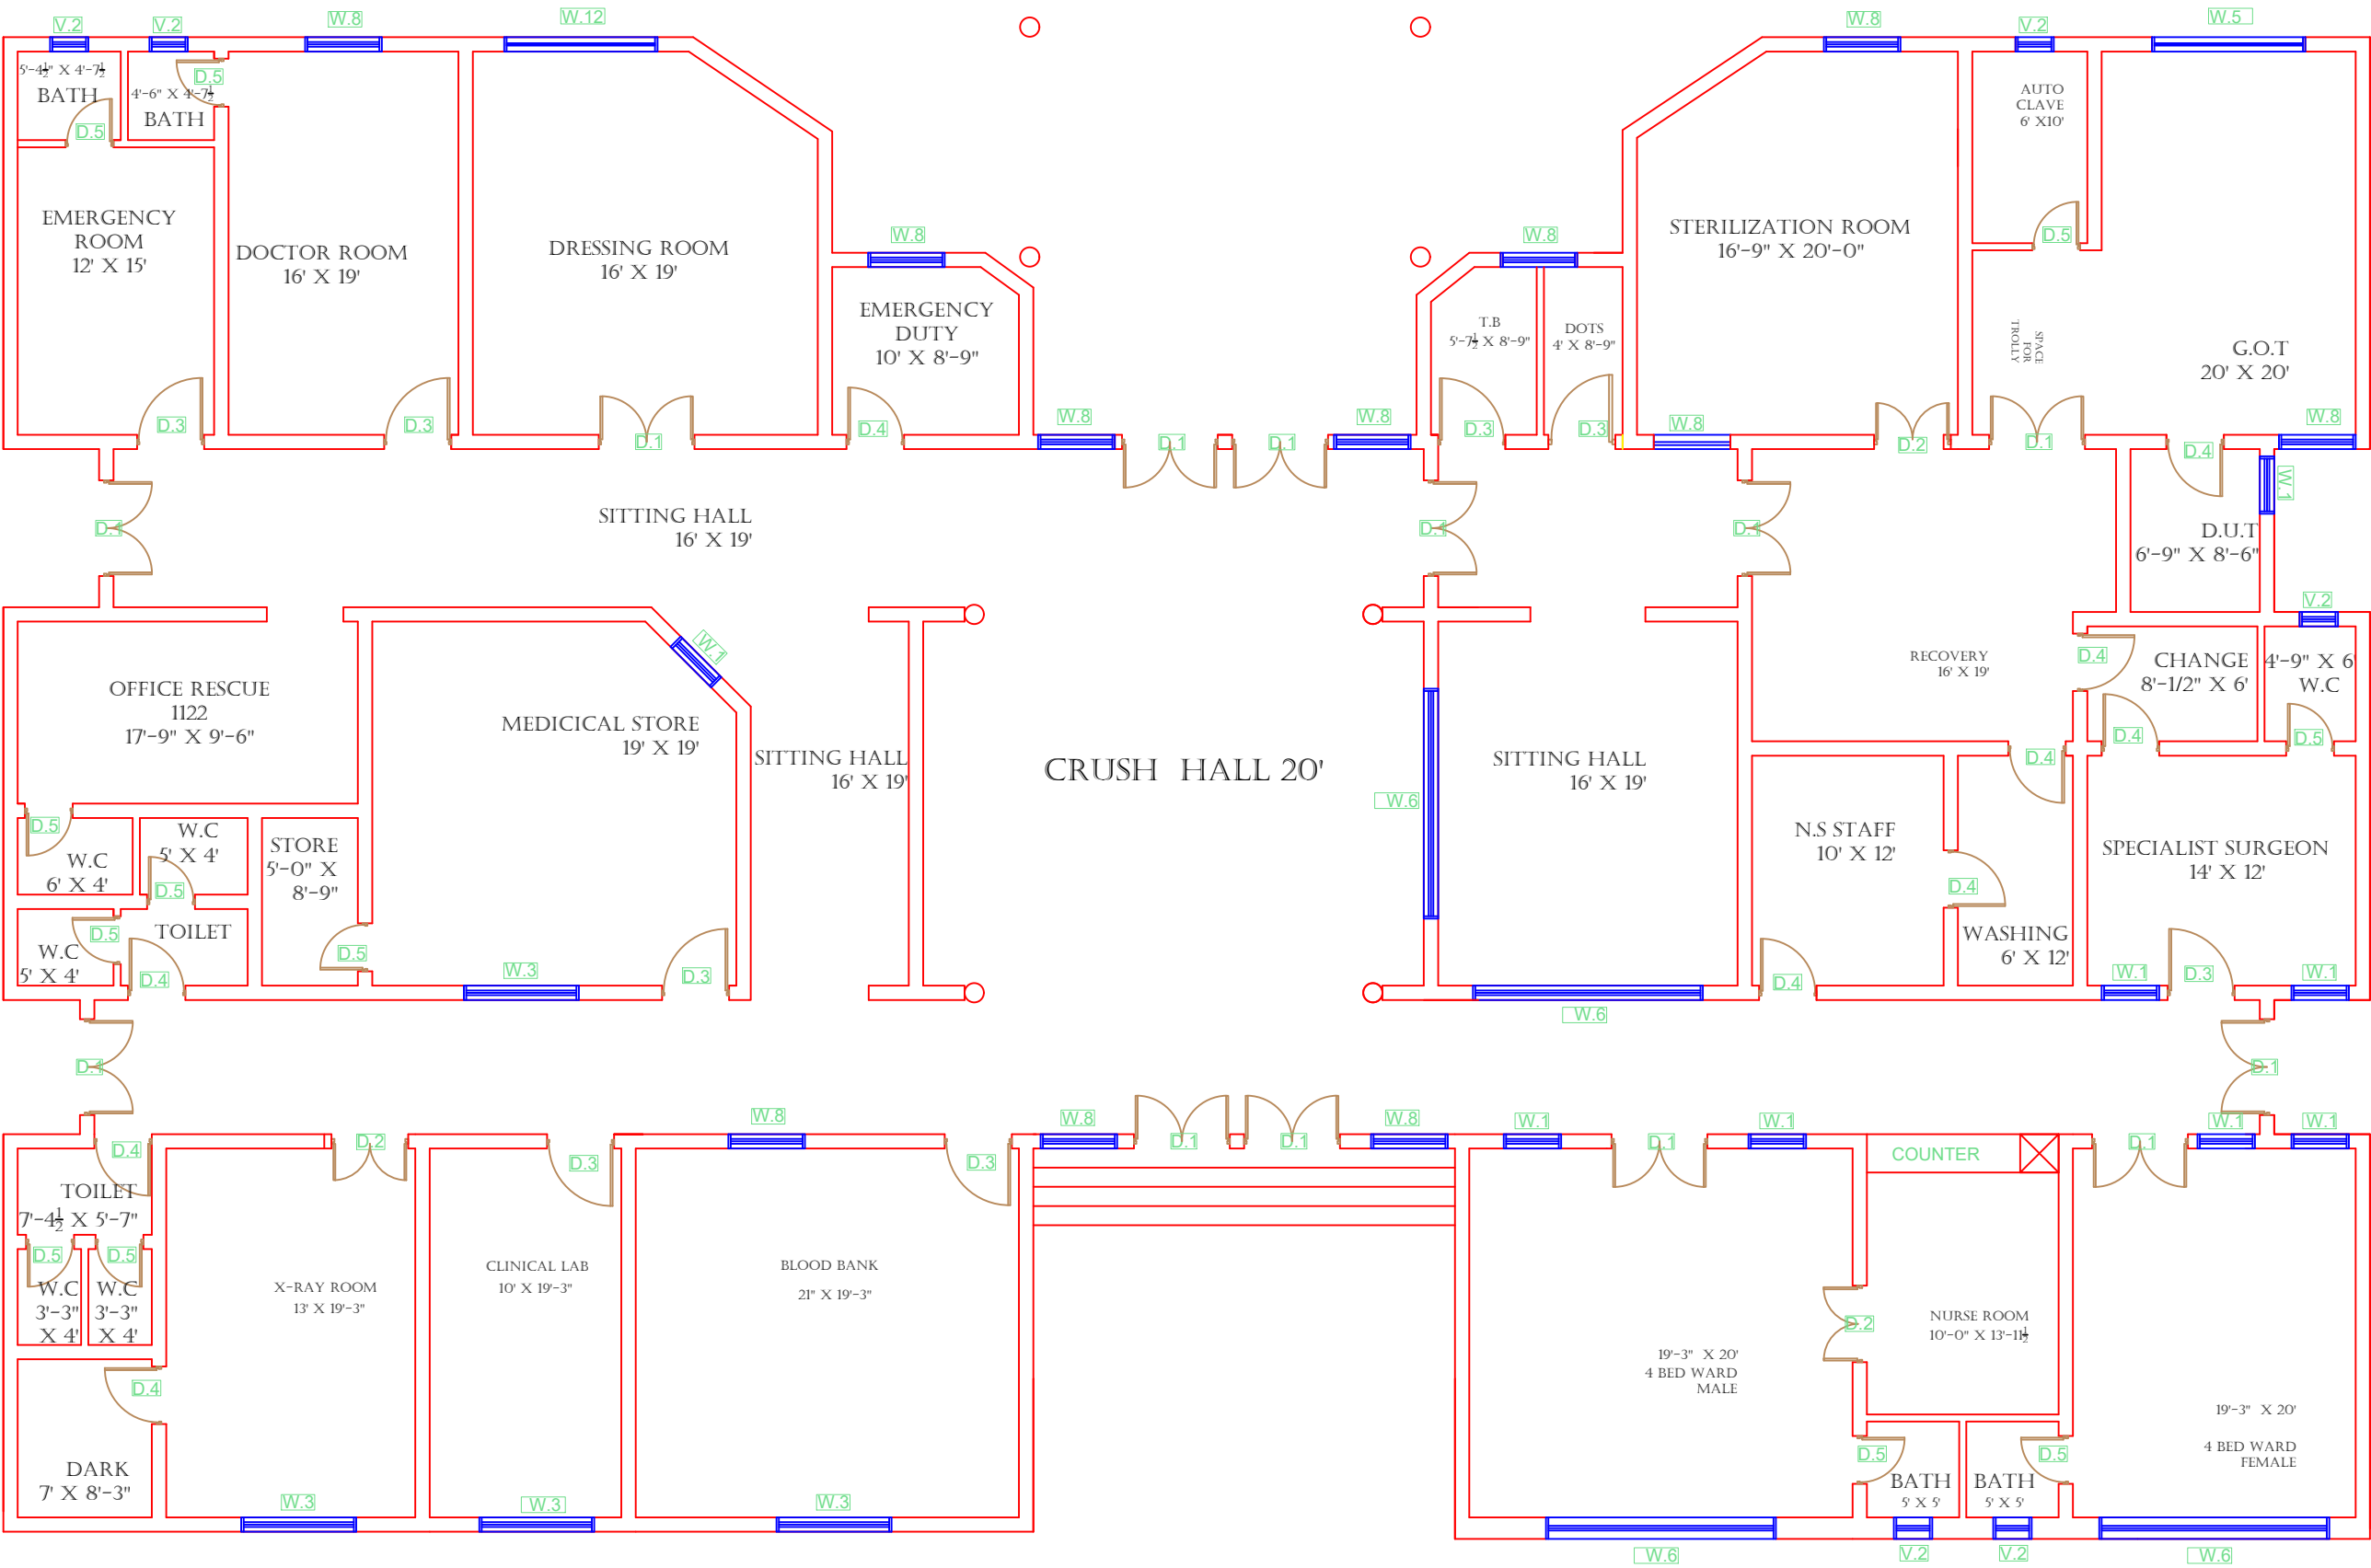

LEGENDS:

RESIDENTIAL AREA	
ROAD	
WALL	
POWER LINE	
OHT	
TREE	
MAN HOLE	
TUBE WELL	
LIGHT POLE	
LAWNS	
EARTHEN AREAS	
ASPHALTS ROADS	
TOUGH PAVERS	
P.C.C / PLINTH PROTECTION	
BOUNDARY WALL	
BRICK PAVERS / SOLING	
DRAIN	
TAP	
HAND PUMP	
AIR CONDITIONER	
TUBE LIGHT	
FAN	
ROOF LIGHT	
BULB	

AREA

AREA WITHIN BOUNDARY WALL	465338.09 SFT
AREA OF CLINICAL BLOCK	43854.59 SFT
PLINTH AREA OF BLOCK	43854.59 SFT

OPENING SCHEDULE OF DOORS AND WINDOWS

DOORS	WIDTH	HEIGHT	WINDOWS	WIDTH	HEIGHT
D1	5'-0"	7'-0"	W1	3'-0"	5'-0"
D2	4'-0"	7'-0"	W2	3'-6"	5'-0"
D3	3'-6"	7'-0"	W3	6'-0"	5'-0"
D4	3'-0"	7'-0"	W4	4'-6"	5'-0"
D5	2'-6"	7'-0"	W5	8'-0"	5'-0"
D6	6'-0"	7'-0"	W6	12'-0"	5'-0"
VENTS	WIDTH	HEIGHT	W7	2'-6"	5'-0"
V1	1'-6"	2'-0"	W8	4'-0"	5'-0"
V2	2'-0"	2'-0"	W9	5'-0"	5'-0"
V3	3'-0"	2'-0"	W0	2'-0"	5'-0"

Project:
CAD MAPPING OF TEHSIL HEAD QUARTER HOSPITALS, PUNJAB

Client:

GOVERNMENT OF THE PUNJAB
PRIMARY & SECONDARY
HEALTHCARE DEPARTMENT

Consultant:

SKAFS CONSULTANT (Pvt.)
Limited
ENGINEERING AND ENVIRONMENT
CONSULTANT

 
Drawing Title:
**THQ PIND DADEN KHAN
CLINICAL BLOCK PLAN (PART 2)**

Drawing No.
SKAFS/PIND DADEN KHAN/10

CLINICAL BLOCK OF THQ HOSPITAL PIND DADEN KHAN
GROUND FLOOR PART 3



LEGENDS:

RESIDENTIAL AREA	
ROAD	
WALL	
POWER LINE	
OHT	
TREE	
MAN HOLE	
TUBE WELL	
LIGHT POLE	
LAWNS	
EARTHEN AREAS	
ASPHALT ROADS	
TOUGH PAVERS	
P.C.C / PLINTH PROTECTION	
BOUNDARY WALL	
BRICK PAVERS / SOLING	
DRAIN	
TAP	
HAND PUMP	
AIR CONDITIONER	
TUBE LIGHT	
FAN	
ROOF LIGHT	
BULB	

AREA	
AREA WITHIN BOUNDARY WALL	465338.09 SFT
AREA OF CLINICAL BLOCK	43854.59 SFT
PLINTH AREA OF BLOCK	43854.59 SFT

OPENING SCHEDULE OF DOORS AND WINDOWS					
DOORS	WIDTH	HEIGHT	WINDOWS	WIDTH	HEIGHT
D1	5'-0"	7'-0"	W1	3'-0"	5'-0"
D2	4'-0"	7'-0"	W2	3'-6"	5'-0"
D3	3'-6"	7'-0"	W3	6'-0"	5'-0"
D4	3'-0"	7'-0"	W4	4'-6"	5'-0"
D5	2'-6"	7'-0"	W5	8'-0"	5'-0"
D6	6'-0"	7'-0"	W6	12'-0"	5'-0"
VENTS	WIDTH	HEIGHT	W7	2'-6"	5'-0"
V1	1'-6"	2'-0"	W8	4'-0"	5'-0"
V2	2'-0"	2'-0"	W9	5'-0"	5'-0"
V3	3'-0"	2'-0"	W0	2'-0"	5'-0"

Project:
**CAD MAPPING OF TEHSIL
HEAD QUARTER HOSPITALS,
PUNJAB**



Client:  GOVERNMENT OF THE PUNJAB PRIMARY & SECONDARY HEALTHCARE DEPARTMENT	Consultant:  SKAFS CONSULTANT (Pvt.) Limited <i>ENGINEERING AND ENVIRONMENTAL CONSULTANT</i>
--	---

Drawing Title: **THQ PIND DADEN KHAN
CLINICAL BLOCK PLAN (PART 3)**

Drawing No. **SKAFS/PIND DADEN KHAN/11**

ELECTRICAL LAYOUT OF THQ HOSPITAL PIND DADEN KHAN

GROUND FLOOR

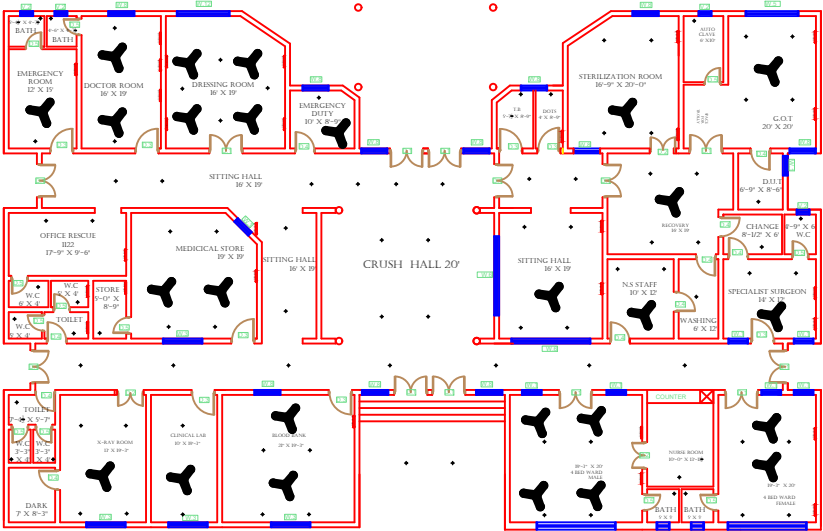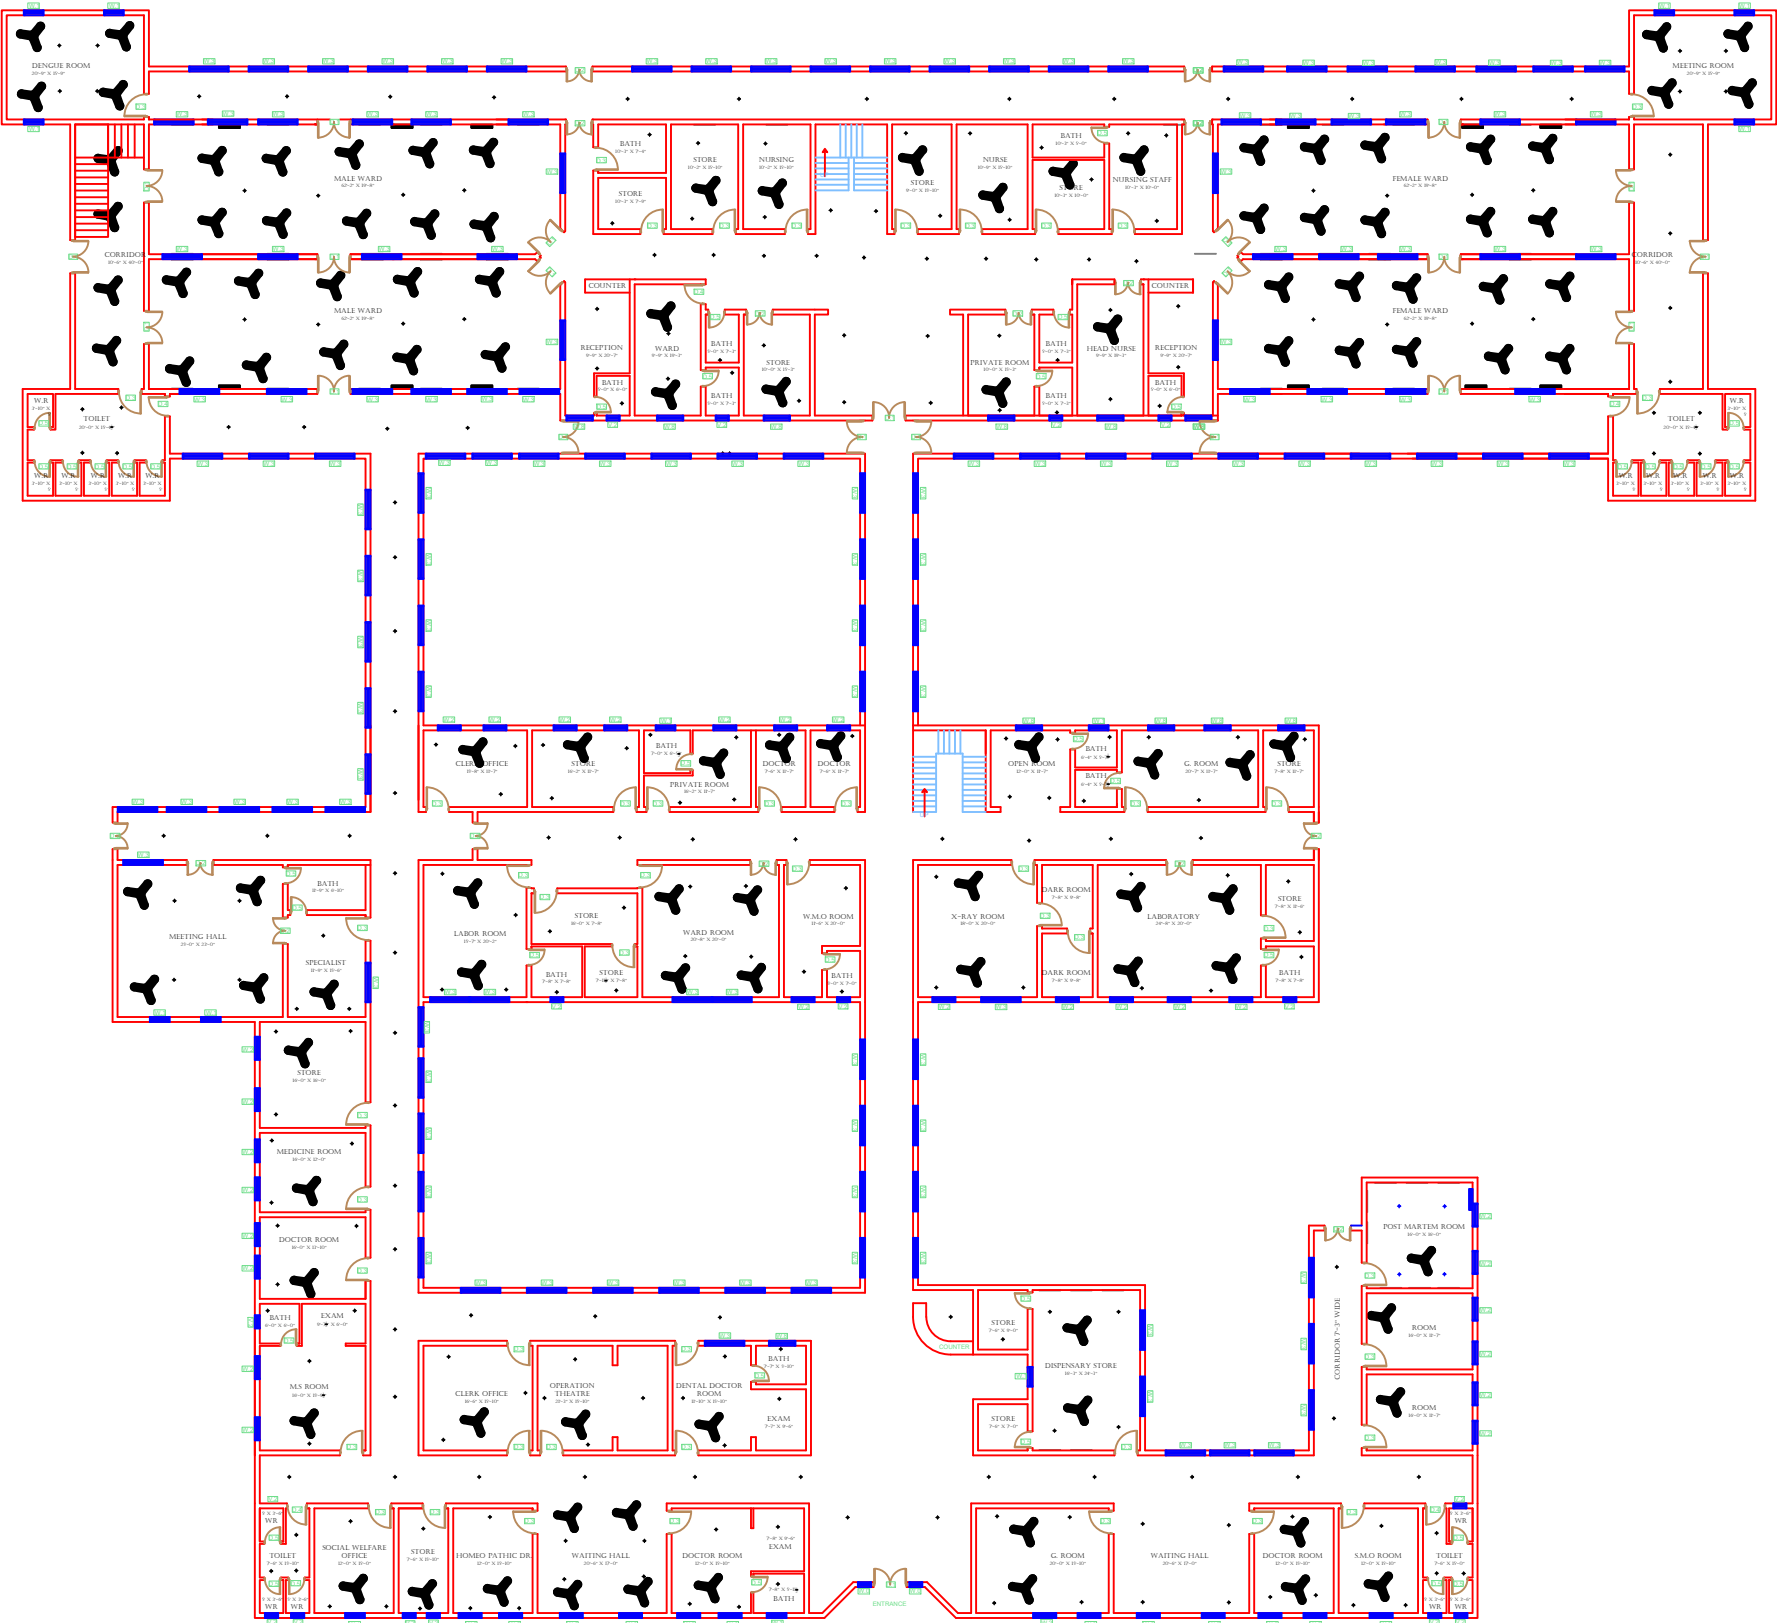

LEGENDS:

RESIDENTIAL AREA

ROAD

WALL

POWER LINE

OHT

TREE

MAN HOLE

TUBE WELL

LIGHT POLE

LAWNS

EARTHEN AREAS

ASPHALTS ROADS

TOUGH PAVERS

P.C.C / PLINTH PROTECTION

BOUNDARY WALL

BRICK PAVERS / SOLING

DRAIN

TAP

HAND PUMP

AIR CONDITIONER

TUBE LIGHT

FAN

ROOF LIGHT

BULB

AREA

AREA WITHIN BOUNDARY WALL

AREA OF CLINICAL BLOCK

PLINTH AREA OF BLOCK

465338.09 SFT

43854.59 SFT

43854.59 SFT

OPENING SCHEDULE OF DOORS AND WINDOWS

DOORS	WIDTH	HEIGHT	WINDOWS	WIDTH	HEIGHT
D1	5'-0"	7'-0"	W1	3'-0"	5'-0"
D2	4'-0"	7'-0"	W2	3'-6"	5'-0"
D3	3'-6"	7'-0"	W3	6'-0"	5'-0"
D4	3'-0"	7'-0"	W4	4'-6"	5'-0"
D5	2'-6"	7'-0"	W5	8'-0"	5'-0"
D6	6'-0"	7'-0"	W6	12'-0"	5'-0"
VENTS	WIDTH	HEIGHT	W7	2'-6"	5'-0"
V1	1'-6"	2'-0"	W8	4'-0"	5'-0"
V2	2'-0"	2'-0"	W9	5'-0"	5'-0"
V3	3'-0"	2'-0"	W0	2'-0"	5'-0"

Project:

CAD MAPPING OF TEHSIL HEAD QUARTER HOSPITALS, PUNJAB

Client:

GOVERNMENT OF THE PUNJAB
PRIMARY & SECONDARY
HEALTHCARE DEPARTMENT

Consultant:

SKAFS CONSULTANT (Pvt.) Limited
ENGINEERING AND ENVIRONMENT
CONSULTANT

Drawing Title:

THQ PIND DADEN KHAN
ELECTRICAL PLAN (GROUND FLOOR)

Drawing No.

SKAFS/PIND DADEN KHAN/12