


MASTER PLAN OF THQ HOSPITAL PINDI BHATTIYAN

PART 1

PART 2

PART 3

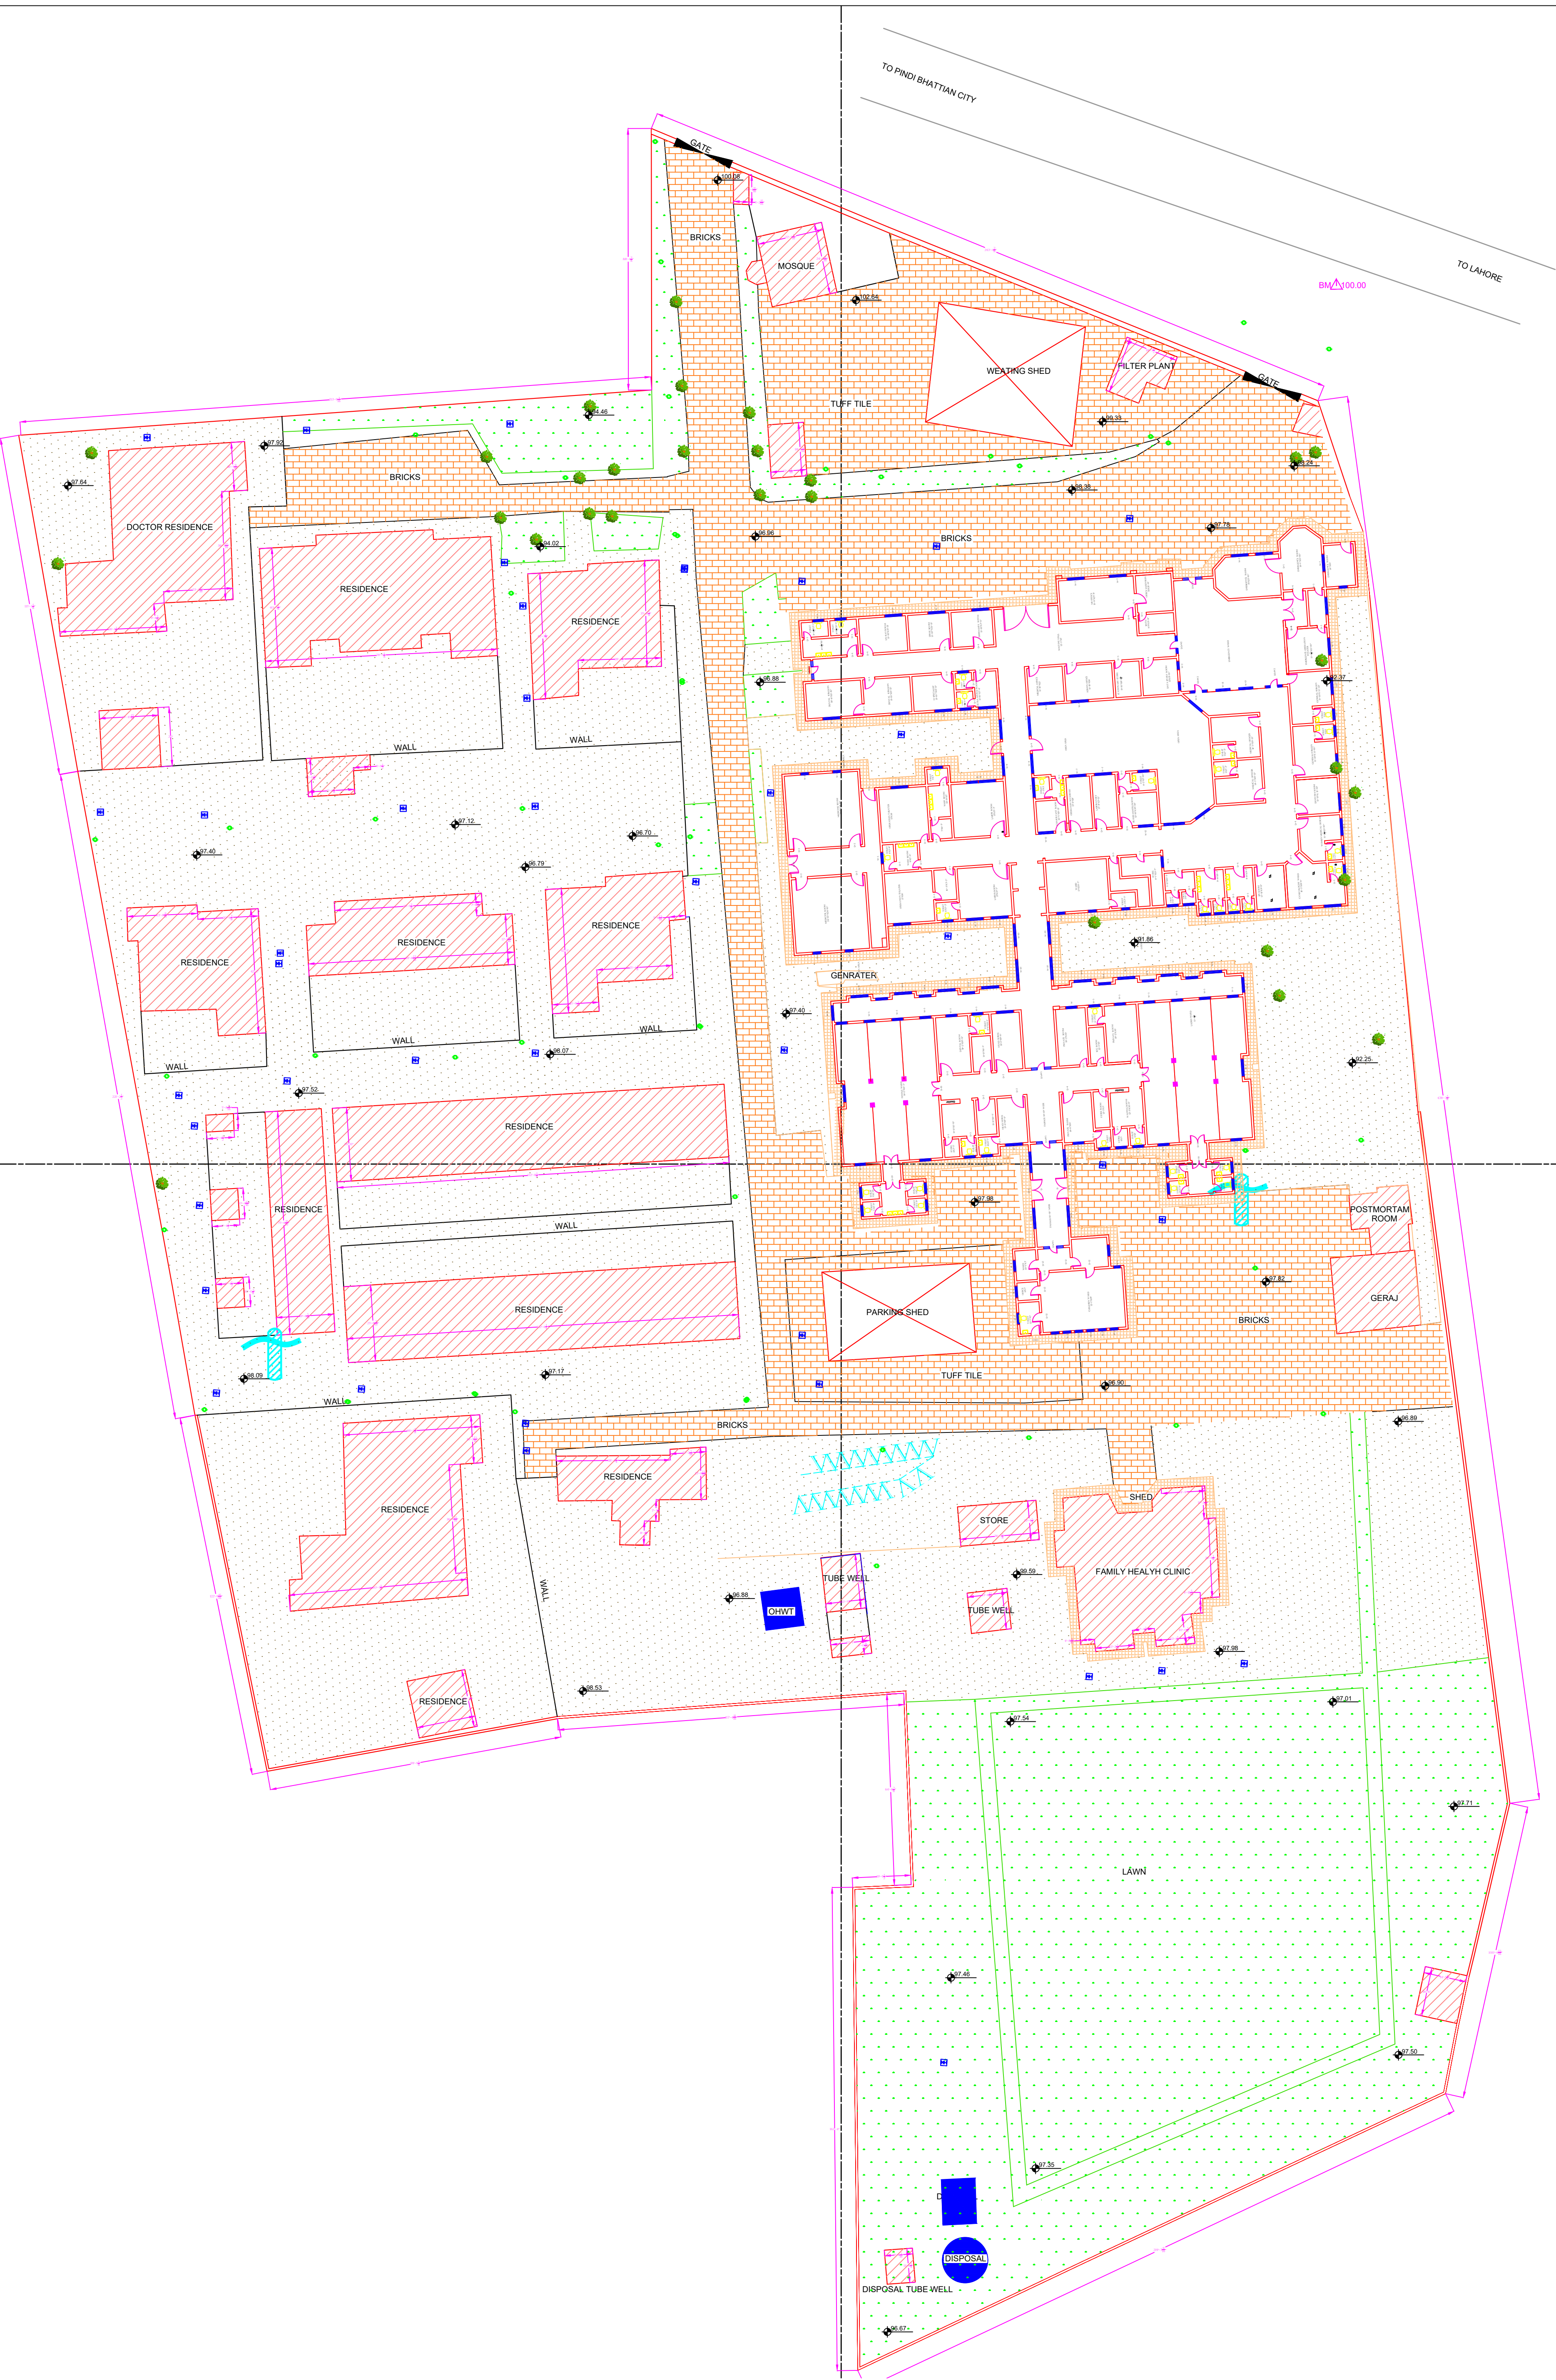PART 4



Legends:

RESIDENTIAL AREA	
ROAD	
WALL	
POWER LINE	
OHT	
TREE	
MANHOLE	
TUBE WELL	
LIGHT POLE	
LAWNS	
EARTHEN AREAS	
ASPHALTS ROADS	
TOUGH PAVERS	
P.C.C /PLINTH PROTECTION	
BOUNDARY WALL	
TAP	
HAND PUMP	
BRICK PAVERS	
AIR CONDITIONER	
TUBE LIGHT	
FAN	
ROOF LIGHT	
BULB	

AREA	
AREA WITHIN BOUNDARY WALL	236746.91 SFT
AREA OF CLINICAL BLOCK	29746.37 SFT
PLINTH AREA OF BLOCK	SFT

OPENING SCHEDULE OF DOORS AND WINDOWS					
DOORS	WIDTH	HEIGHT	WINDOWS	WIDTH	HEIGHT
D1	5'-0"	7'-0"	W1	2'-6"	2'-6"
D2	4'-0"	7'-0"	W2	3'-0"	3'-0"
D3	2'-6"	7'-0"	W3	4'-0"	4'-0"
D4	3'-6"	7'-0"	W4	5'-0"	5'-0"
D5	6'-0"	7'-0"	W5	4'-6"	4'-6"
D6	7'-0"	7'-0"	W6	5'-10"	5'-10"
D7	12'-0"	7'-0"	W7	6'-0"	6'-0"
D8	4'-6"	7'-0"	W8		
D9	10'-0"	7'-0"	V2		

Client:



GOVERNMENT OF THE PUNJAB
PRIMARY & SECONDARY
HEALTHCARE DEPARTMENT

Project:

CAD MAPPING OF TEHSIL
HEAD QUARTER HOSPITALS,
PUNJAB

Consultant:



SKAFS CONSULTANT (Pvt.) Limited
ENGINEERING AND ENVIRONMENT CONSULTANT

Drawing Title:

THQ PINDI BHATTIAN
HOSPITAL MASTER PLAN

Authorized By: SKAFS	Reviewed By Co-Team Leader	Scale: 1:350
-------------------------	-------------------------------	-----------------

Prepared By: CAD TEAMS	Date: FEB, 2017
---------------------------	--------------------

Drawing No. SKAFS/PINDI BHATTIAN /03

MASTER PLAN OF THQ HOSPITAL PINDI BHATTIYAN

PART 1



Legends:

RESIDENTIAL AREA	
ROAD	
WALL	
POWER LINE	
OHT	
TREE	
MANHOLE	
TUBE WELL	
LIGHT POLE	
LAWNS	
EARTHEN AREAS	
ASPHALTS ROADS	
TOUGH PAVERS	
P.C.C /PLINTH PROTECTION	
BOUNDARY WALL	
TAP	
HAND PUMP	
BRICK PAVERS	
AIR CONDITIONER	
TUBE LIGHT	
FAN	
ROOF LIGHT	
BULB	

AREA	
AREA WITHIN BOUNDARY WALL	236746.91 SFT
AREA OF CLINICAL BLOCK	29746.37 SFT
PLINTH AREA OF BLOCK	SFT

OPENING SCHEDULE OF DOORS AND WINDOWS					
DOORS	WIDTH	HEIGHT	WINDOWS	WIDTH	HEIGHT
D1	5'-0"	7'-0"	W1	2'-6"	2'-6"
D2	4'-0"	7'-0"	W2	3'-0"	3'-0"
D3	2'-6"	7'-0"	W3	4'-0"	4'-0"
D4	3'-6"	7'-0"	W4	5'-0"	5'-0"
D5	6'-0"	7'-0"	W5	4'-6"	4'-6"
D6	7'-0"	7'-0"	W6	5'-10"	5'-10"
D7	12'-0"	7'-0"	W7	6'-0"	6'-0"
D8	4'-6"	7'-0"	W8		
D9	10'-0"	7'-0"	V2		

Client:

GOVERNMENT OF THE PUNJAB
PRIMARY & SECONDARY
HEALTHCARE DEPARTMENT

Project:

CAD MAPPING OF TEHSIL
HEAD QUARTER HOSPITALS,
PUNJAB

Consultant:

SKAFS CONSULTANT (Pvt.) Limited
ENGINEERING AND ENVIRONMENT CONSULTANT


Drawing Title:

THQ PINDI BHATTIAN
HOSPITAL MASTER PLAN
PART 1

Authorized By: SKAFS	Reviewed By: Co-Team Leader	Scale:
Prepared By: CAD TEAMS	Date: FEB, 2017	Sheet:
Drawing No.		SKAFS/PINDI BHATTIAN /04

MASTER PLAN OF THQ HOSPITAL PINDI BHATTIYAN

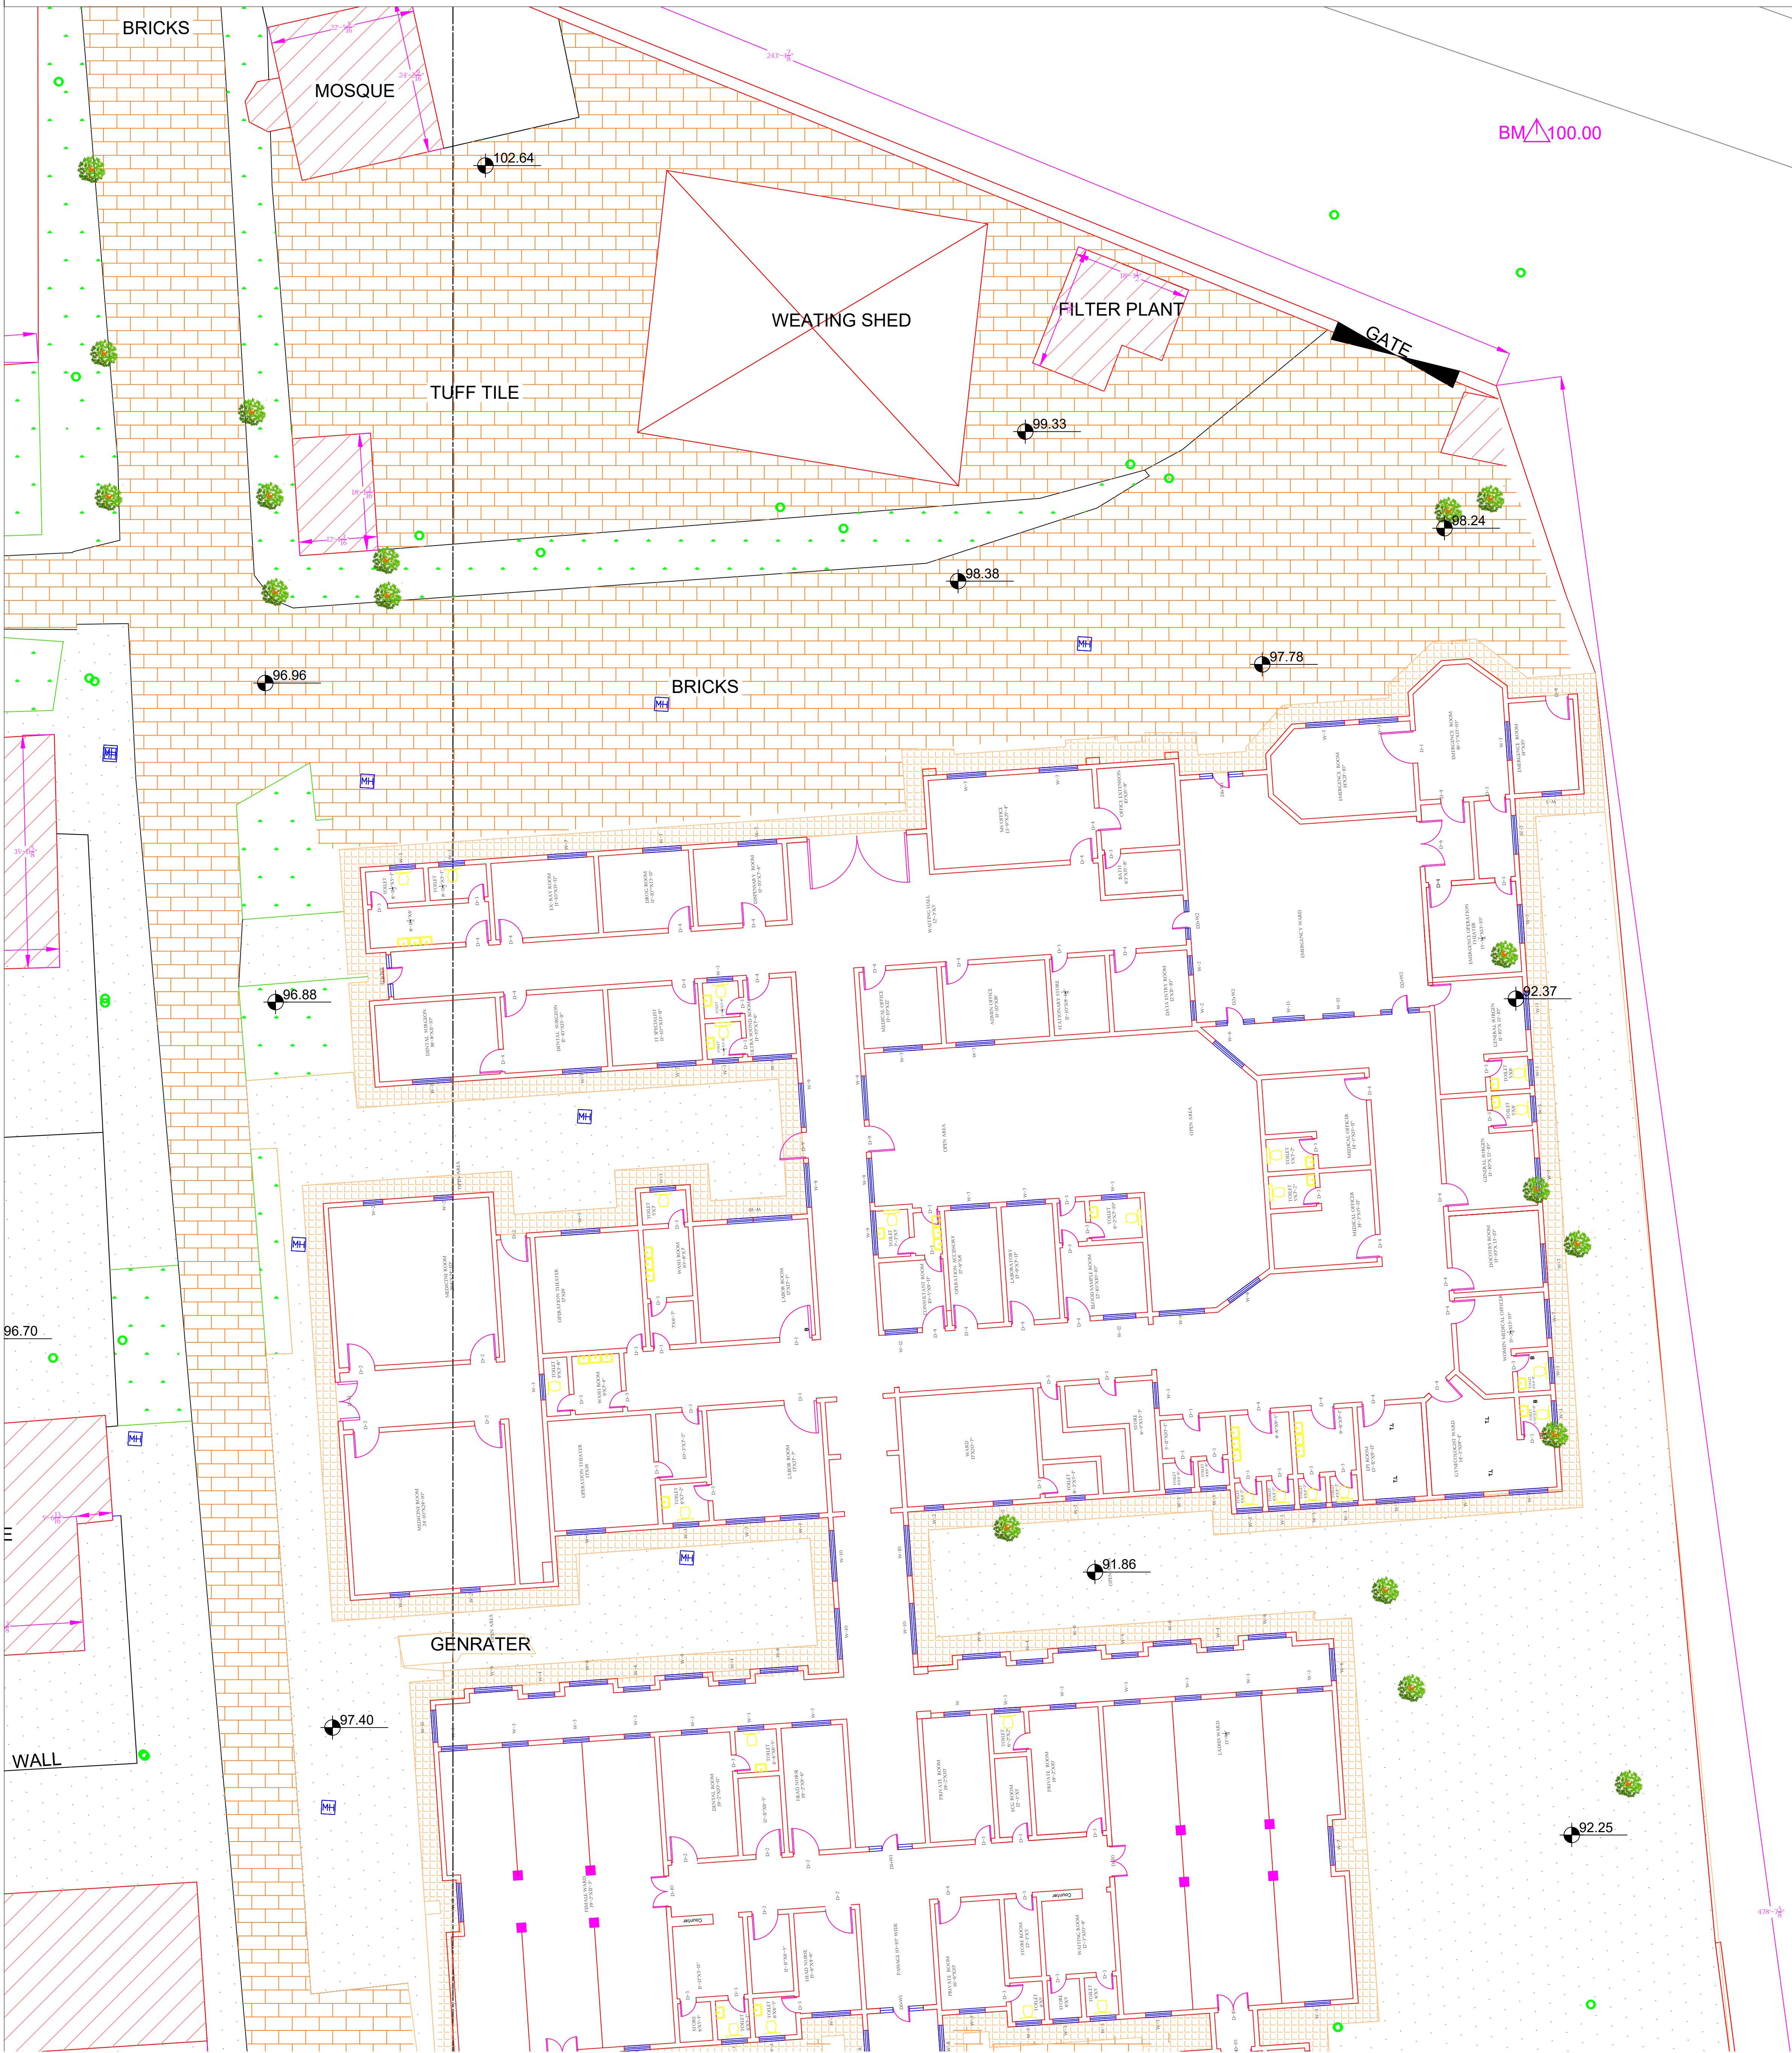PART 2



Legends:

RESIDENTIAL AREA	
ROAD	
WALL	
POWER LINE	
OHT	
TREE	
MANHOLE	
TUBE WELL	
LIGHT POLE	
LAWNS	
EARTHEN AREAS	
ASPHALTS ROADS	
TOUGH PAVERS	
P.C.C /PLINTH PROTECTION	
BOUNDARY WALL	
TAP	
HAND PUMP	
BRICK PAVERS	
AIR CONDITIONER	
TUBE LIGHT	
FAN	
ROOF LIGHT	
BULB	

AREA	
AREA WITHIN BOUNDARY WALL	236746.91 SFT
AREA OF CLINICAL BLOCK	29746.37 SFT
PLINTH AREA OF BLOCK	SFT

OPENING SCHEDULE OF DOORS AND WINDOWS					
DOORS	WIDTH	HEIGHT	WINDOWS	WIDTH	HEIGHT
D1	5'-0"	7'-0"	W1	2'-6"	2'-6"
D2	4'-0"	7'-0"	W2	3'-0"	3'-0"
D3	2'-6"	7'-0"	W3	4'-0"	4'-0"
D4	3'-6"	7'-0"	W4	5'-0"	5'-0"
D5	6'-0"	7'-0"	W5	4'-6"	4'-6"
D6	7'-0"	7'-0"	W6	5'-10"	5'-10"
D7	12'-0"	7'-0"	W7	6'-0"	6'-0"
D8	4'-6"	7'-0"	W8		
D9	10'-0"	7'-0"	V2		

Client:



GOVERNMENT OF THE PUNJAB
PRIMARY & SECONDARY
HEALTHCARE DEPARTMENT

Project:

CAD MAPPING OF TEHSIL
HEAD QUARTER HOSPITALS,
PUNJAB

Consultant:



SKAFS CONSULTANT (Pvt.) Limited
ENGINEERING AND ENVIRONMENT CONSULTANT


Drawing Title:

THQ PINDI BHATTIAN
HOSPITAL MASTER PLAN
PART 2

Authorized By: SKAFS	Reviewed By Co-Team Leader	Scale:
Prepared By: CAD TEAMS	Date: FEB, 2017	Sheet:
Drawing No. SKAFS/PINDI BHATTIAN/05		

MASTER PLAN OF THQ HOSPITAL PINDI BHATTIYAN

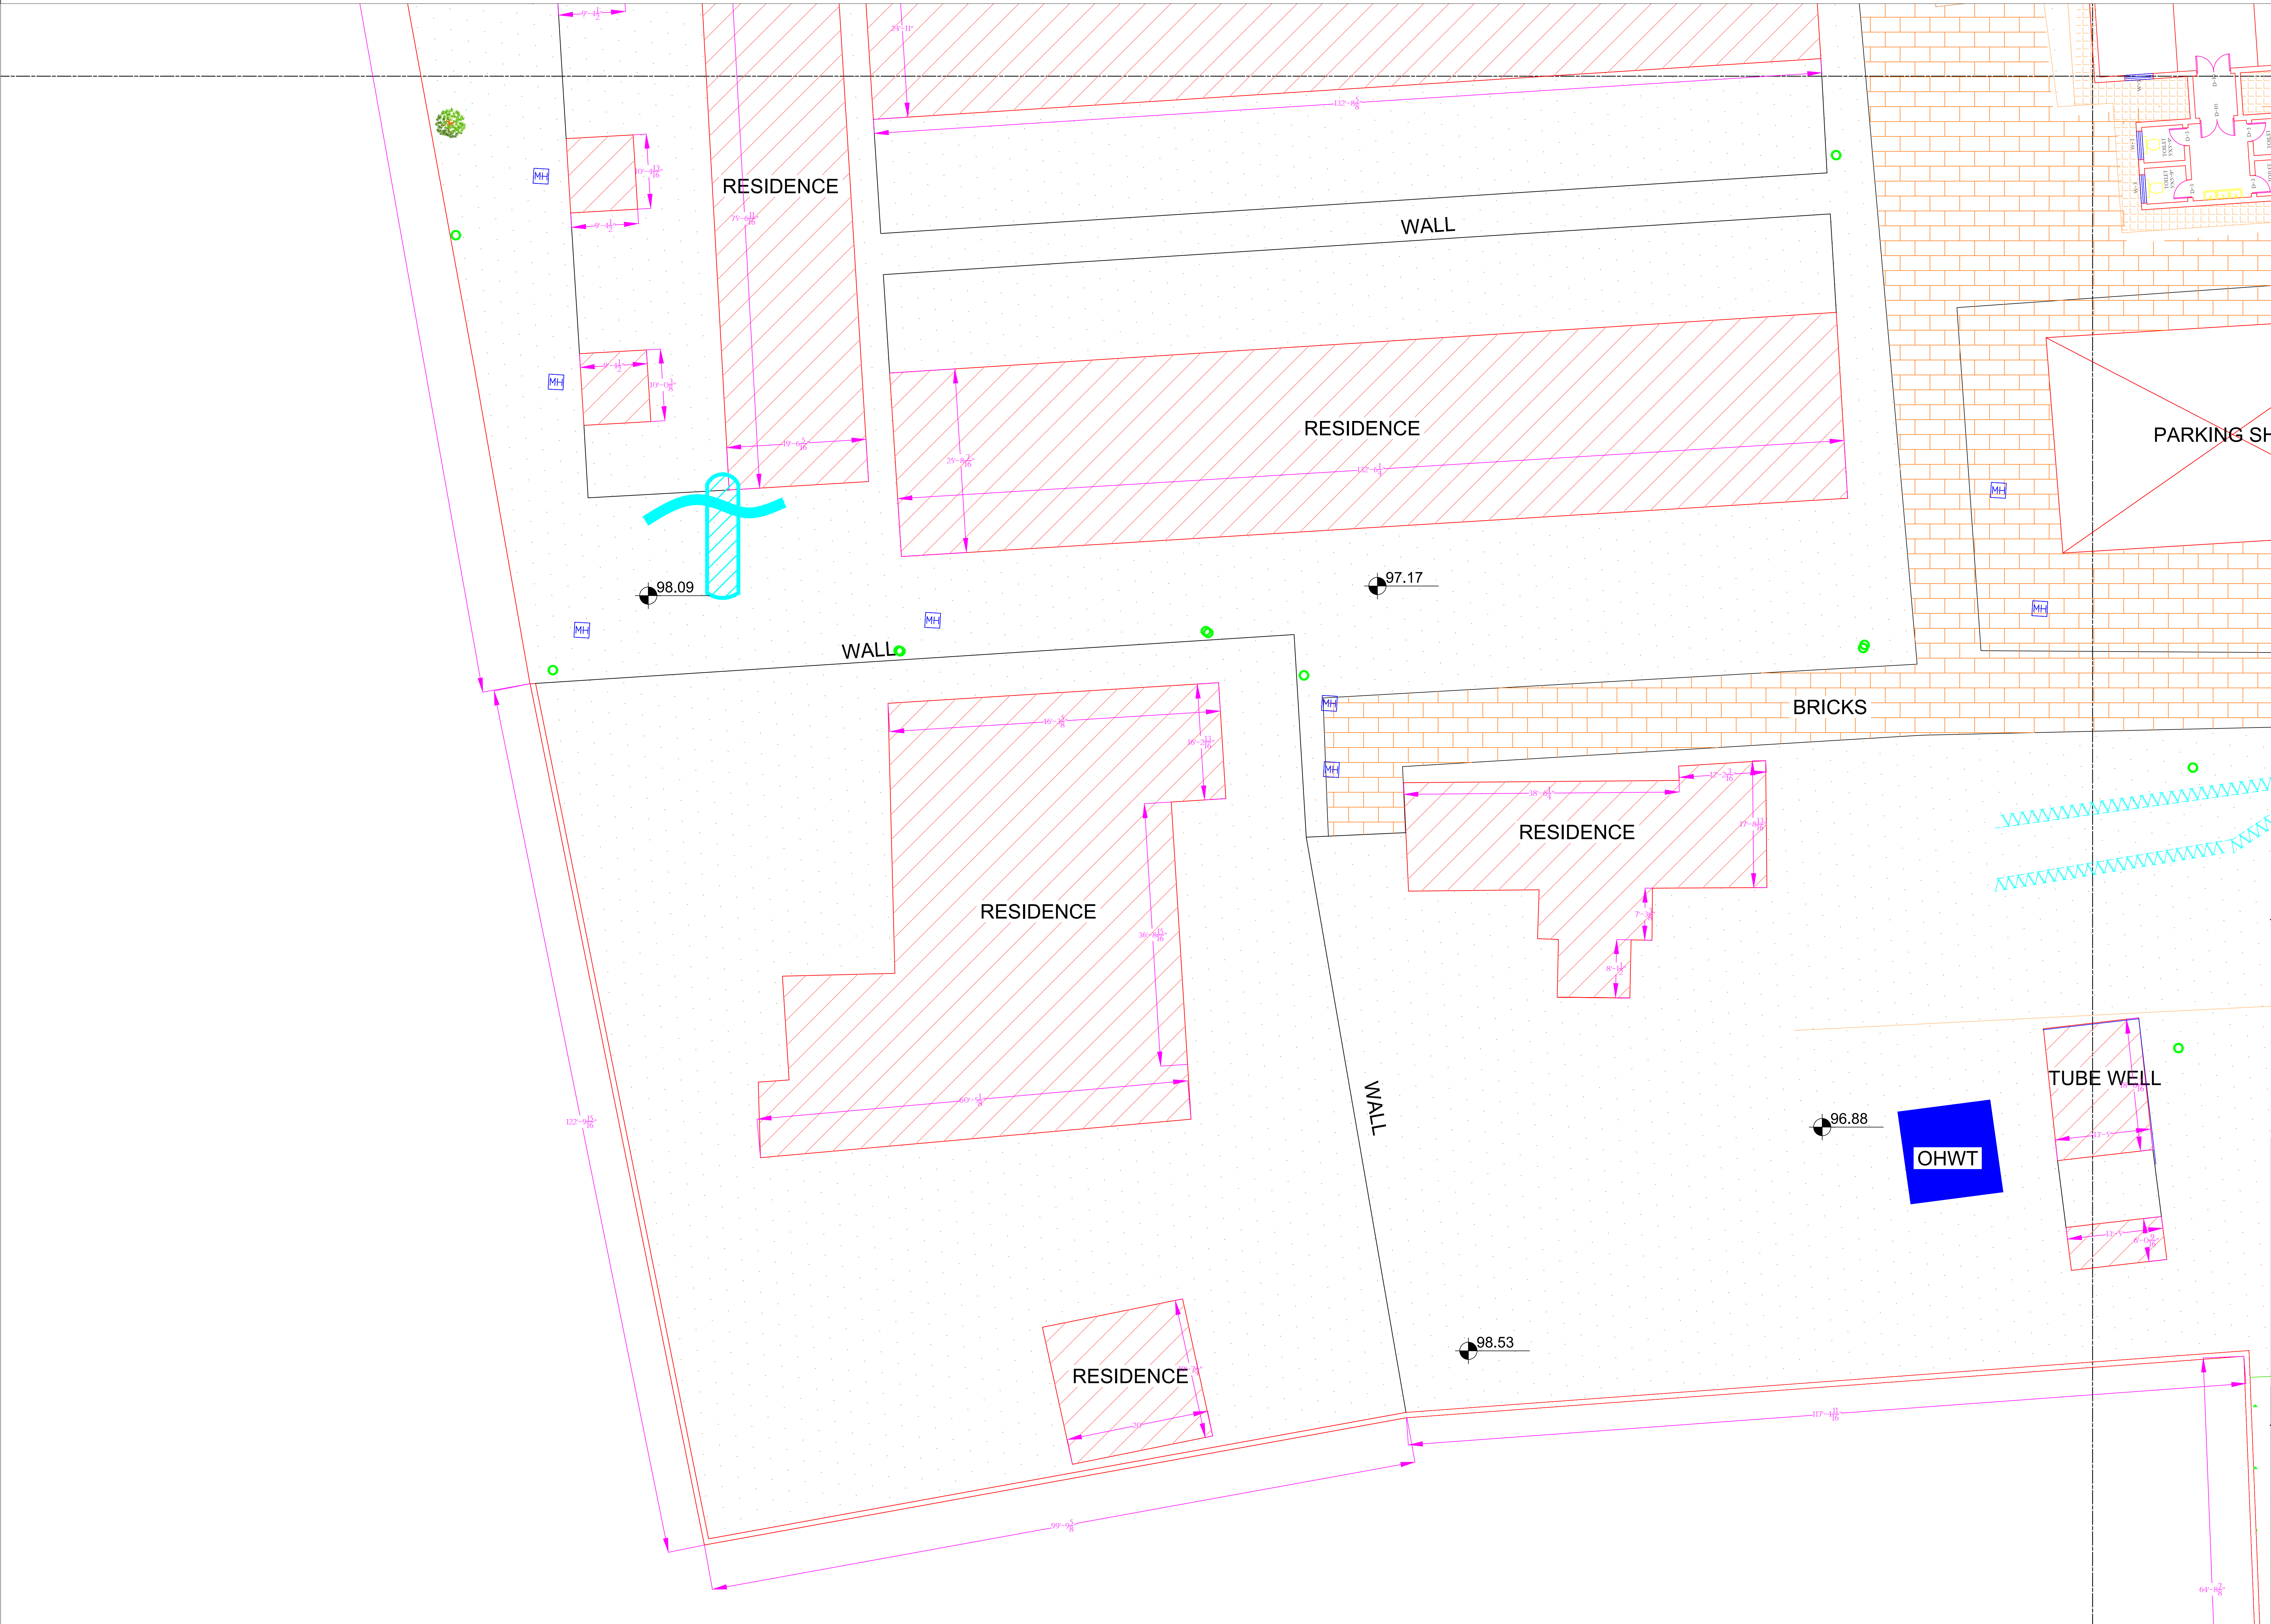PART 3



Legends:

RESIDENTIAL AREA	
ROAD	
WALL	
POWER LINE	
OHT	
TREE	
MANHOLE	
TUBE WELL	
LIGHT POLE	
LAWNS	
EARTHEN AREAS	
ASPHALTS ROADS	
TOUGH PAVERS	
P.C.C /PLINTH PROTECTION	
BOUNDARY WALL	
TAP	
HAND PUMP	
BRICK PAVERS	
AIR CONDITIONER	
TUBE LIGHT	
FAN	
ROOF LIGHT	
BULB	

AREA	
AREA WITHIN BOUNDARY WALL	236746.91 SFT
AREA OF CLINICAL BLOCK	29746.37 SFT
PLINTH AREA OF BLOCK	SFT

OPENING SCHEDULE OF DOORS AND WINDOWS					
DOORS	WIDTH	HEIGHT	WINDOWS	WIDTH	HEIGHT
D1	5'-0"	7'-0"	W1	2'-6"	2'-6"
D2	4'-0"	7'-0"	W2	3'-0"	3'-0"
D3	2'-6"	7'-0"	W3	4'-0"	4'-0"
D4	3'-6"	7'-0"	W4	5'-0"	5'-0"
D5	6'-0"	7'-0"	W5	4'-6"	4'-6"
D6	7'-0"	7'-0"	W6	5'-10"	5'-10"
D7	12'-0"	7'-0"	W7	6'-0"	6'-0"
D8	4'-6"	7'-0"	W8		
D9	10'-0"	7'-0"	V2		

Client:

GOVERNMENT OF THE PUNJAB
PRIMARY & SECONDARY
HEALTHCARE DEPARTMENT

Project:

CAD MAPPING OF TEHSIL
HEAD QUARTER HOSPITALS,
PUNJAB

Consultant:

SKAFS CONSULTANT (Pvt.) Limited
ENGINEERING AND ENVIRONMENT CONSULTANT


Drawing Title:

THQ PINDI BHATTIAN
HOSPITAL MASTER PLAN
PART 3

Authorized By: SKAFS	Reviewed By Co-Team Leader	Scale:
Prepared By: CAD TEAMS	Date: FEB, 2017	
Drawing No.		SKAFS/PINDI BHATTIAN /06

MASTER PLAN OF THQ HOSPITAL PINDI BHATTIYAN

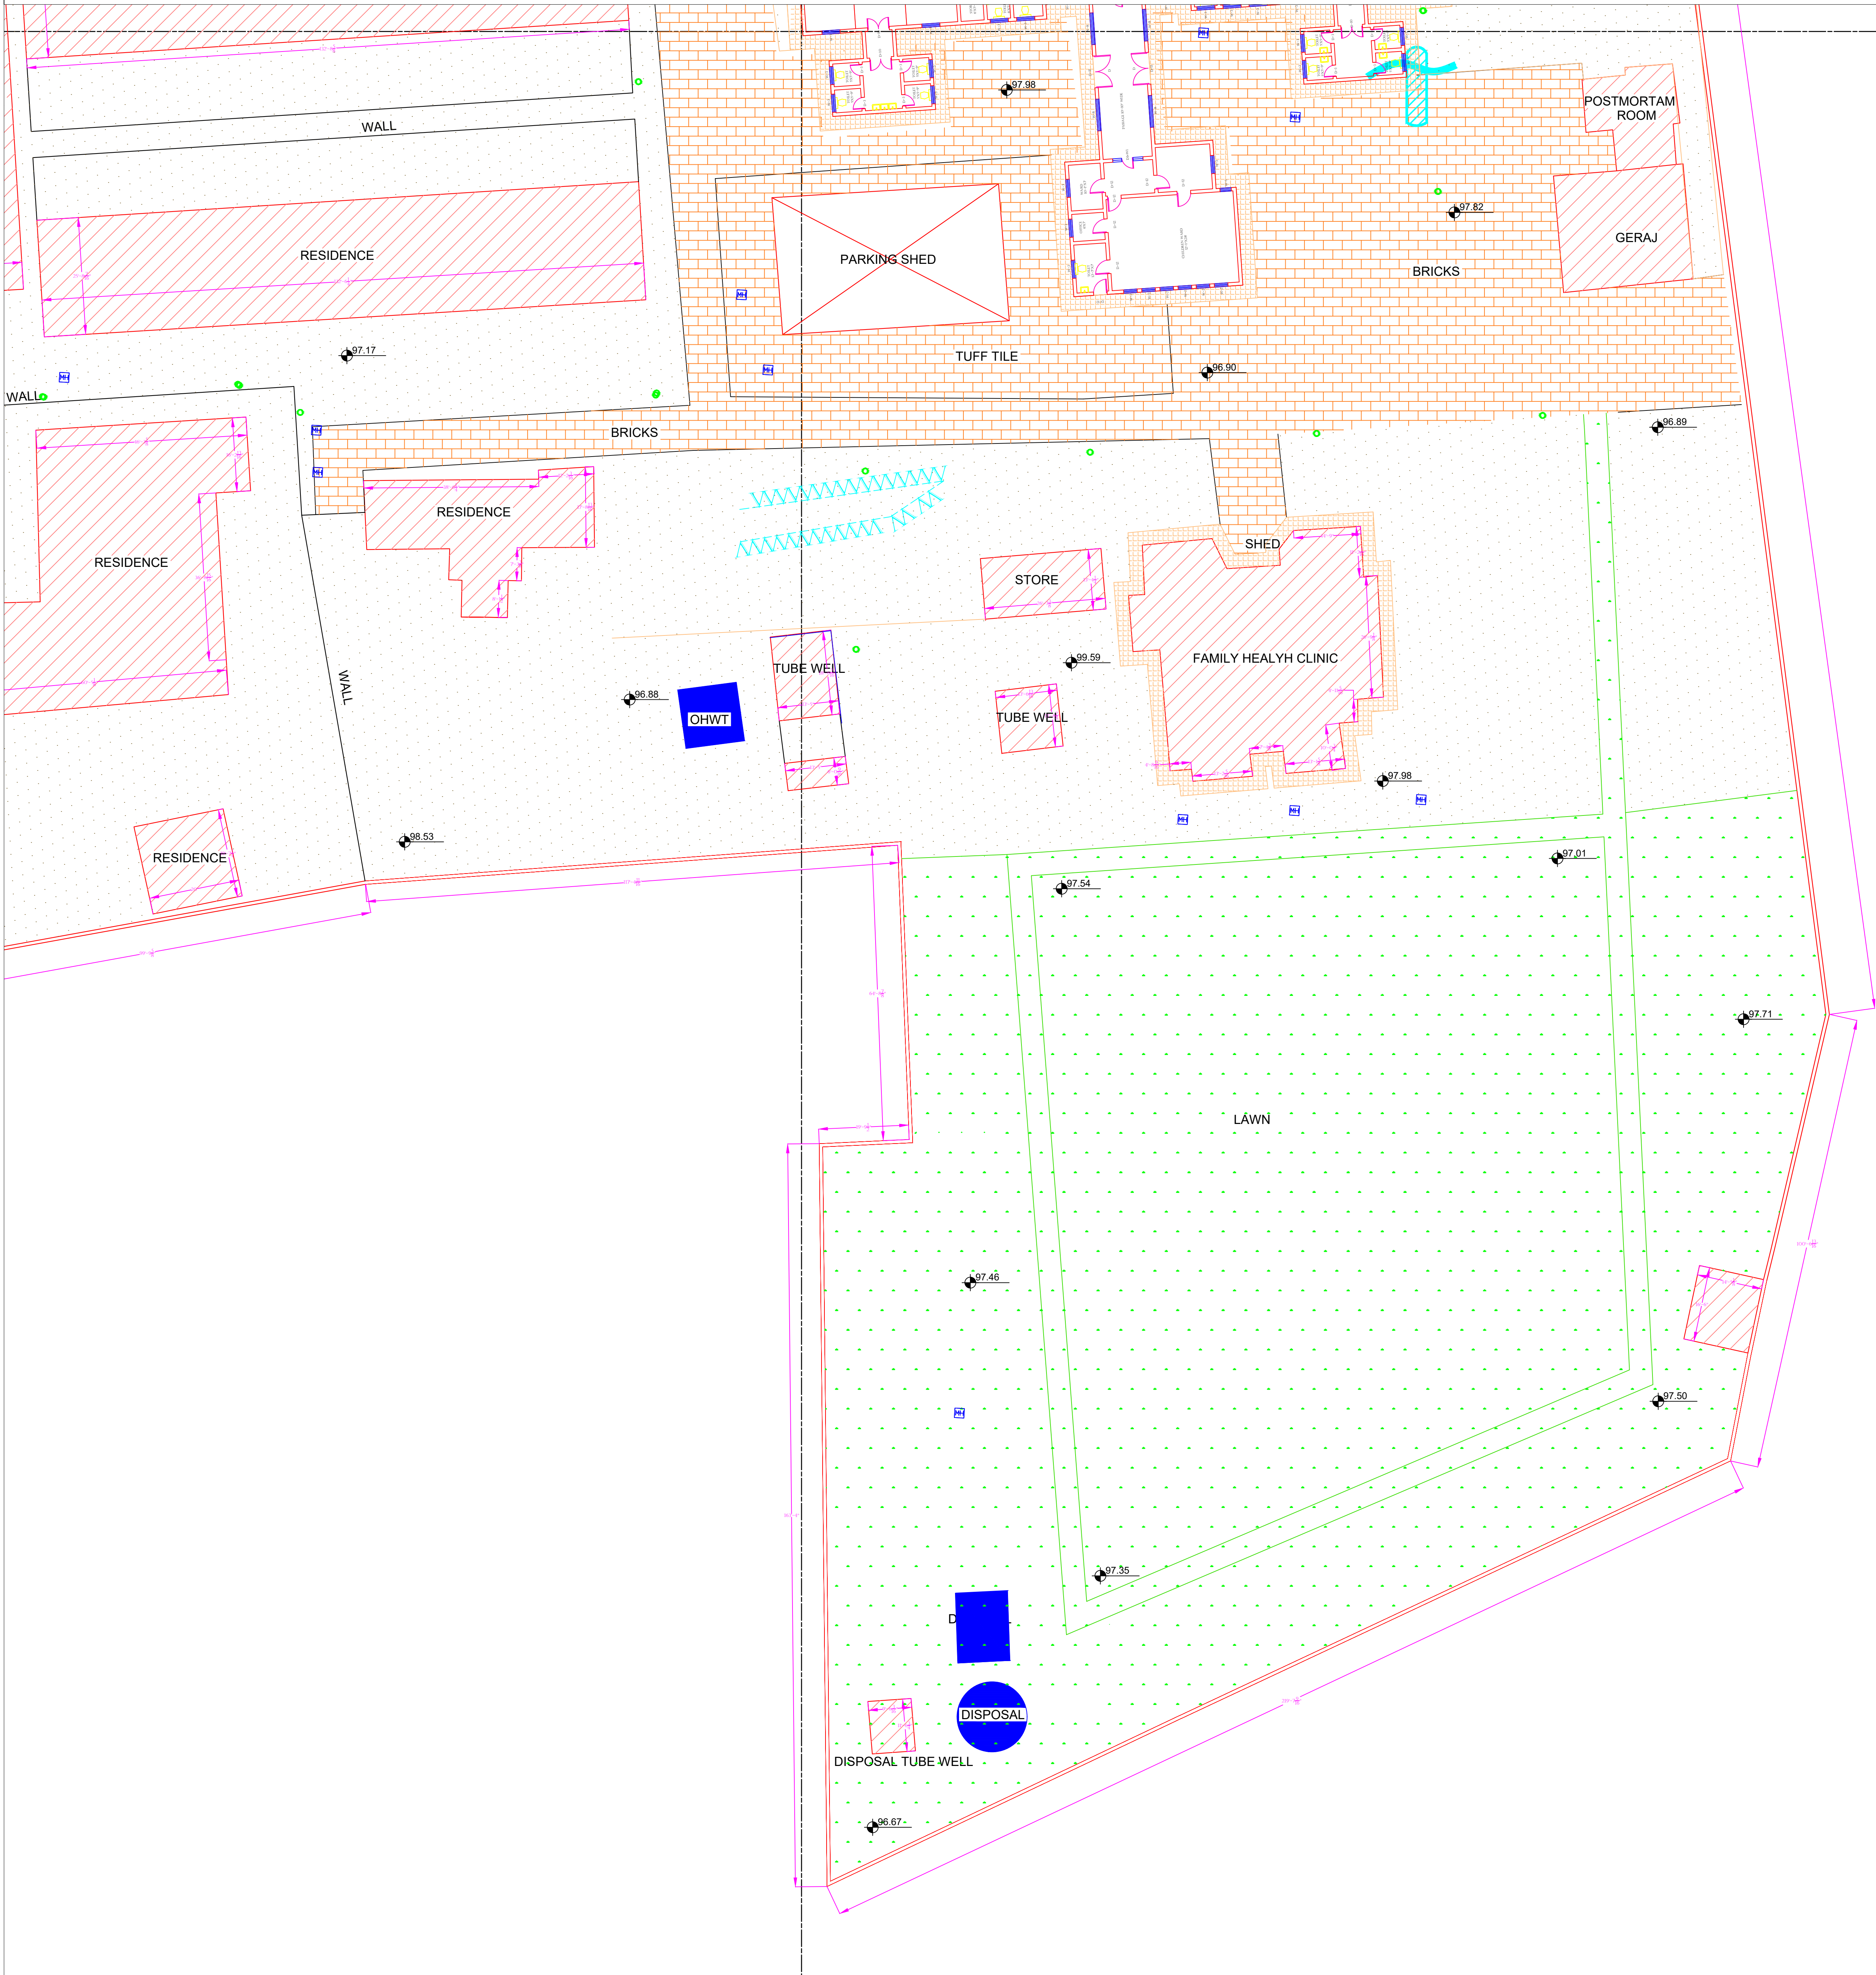PART 4



Legends:

RESIDENTIAL AREA	
ROAD	
WALL	
POWER LINE	
OHT	
TREE	
MANHOLE	
TUBE WELL	
LIGHT POLE	
LAWNS	
EARTHEN AREAS	
ASPHALTS ROADS	
TOUGH PAVERS	
P.C.C /PLINTH PROTECTION	
BOUNDARY WALL	
TAP	
HAND PUMP	
BRICK PAVERS	
AIR CONDITIONER	
TUBE LIGHT	
FAN	
ROOF LIGHT	
BULB	

AREA	
AREA WITHIN BOUNDARY WALL	236746.91 SFT
AREA OF CLINICAL BLOCK	29746.37 SFT
PLINTH AREA OF BLOCK	SFT

OPENING SCHEDULE OF DOORS AND WINDOWS					
DOORS	WIDTH	HEIGHT	WINDOWS	WIDTH	HEIGHT
D1	5'-0"	7'-0"	W1	2'-6"	2'-6"
D2	4'-0"	7'-0"	W2	3'-0"	3'-0"
D3	2'-6"	7'-0"	W3	4'-0"	4'-0"
D4	3'-6"	7'-0"	W4	5'-0"	5'-0"
D5	6'-0"	7'-0"	W5	4'-6"	4'-6"
D6	7'-0"	7'-0"	W6	5'-10"	5'-10"
D7	12'-0"	7'-0"	W7	6'-0"	6'-0"
D8	4'-6"	7'-0"	W8		
D9	10'-0"	7'-0"	V2		

Client:



GOVERNMENT OF THE PUNJAB
PRIMARY & SECONDARY
HEALTHCARE DEPARTMENT

Project:

CAD MAPPING OF TEHSIL
HEAD QUARTER HOSPITALS,
PUNJAB

Consultant:



SKAFS CONSULTANT (Pvt.) Limited
ENGINEERING AND ENVIRONMENT CONSULTANT

Drawing Title:

THQ PINDI BHATTIAN
HOSPITAL MASTER PLAN
PART 4


Authorized By: SKAFS	Reviewed By Co-Team Leader	Scale:
Prepared By: CAD TEAMS	Date: FEB, 2017	
Drawing No. SKAFS/PINDI BHATTIAN /07		

CLINICAL BLOCK OF THQ HOSPITAL PINDI BHATTIYAN

GROUND FLOOR


PART 1

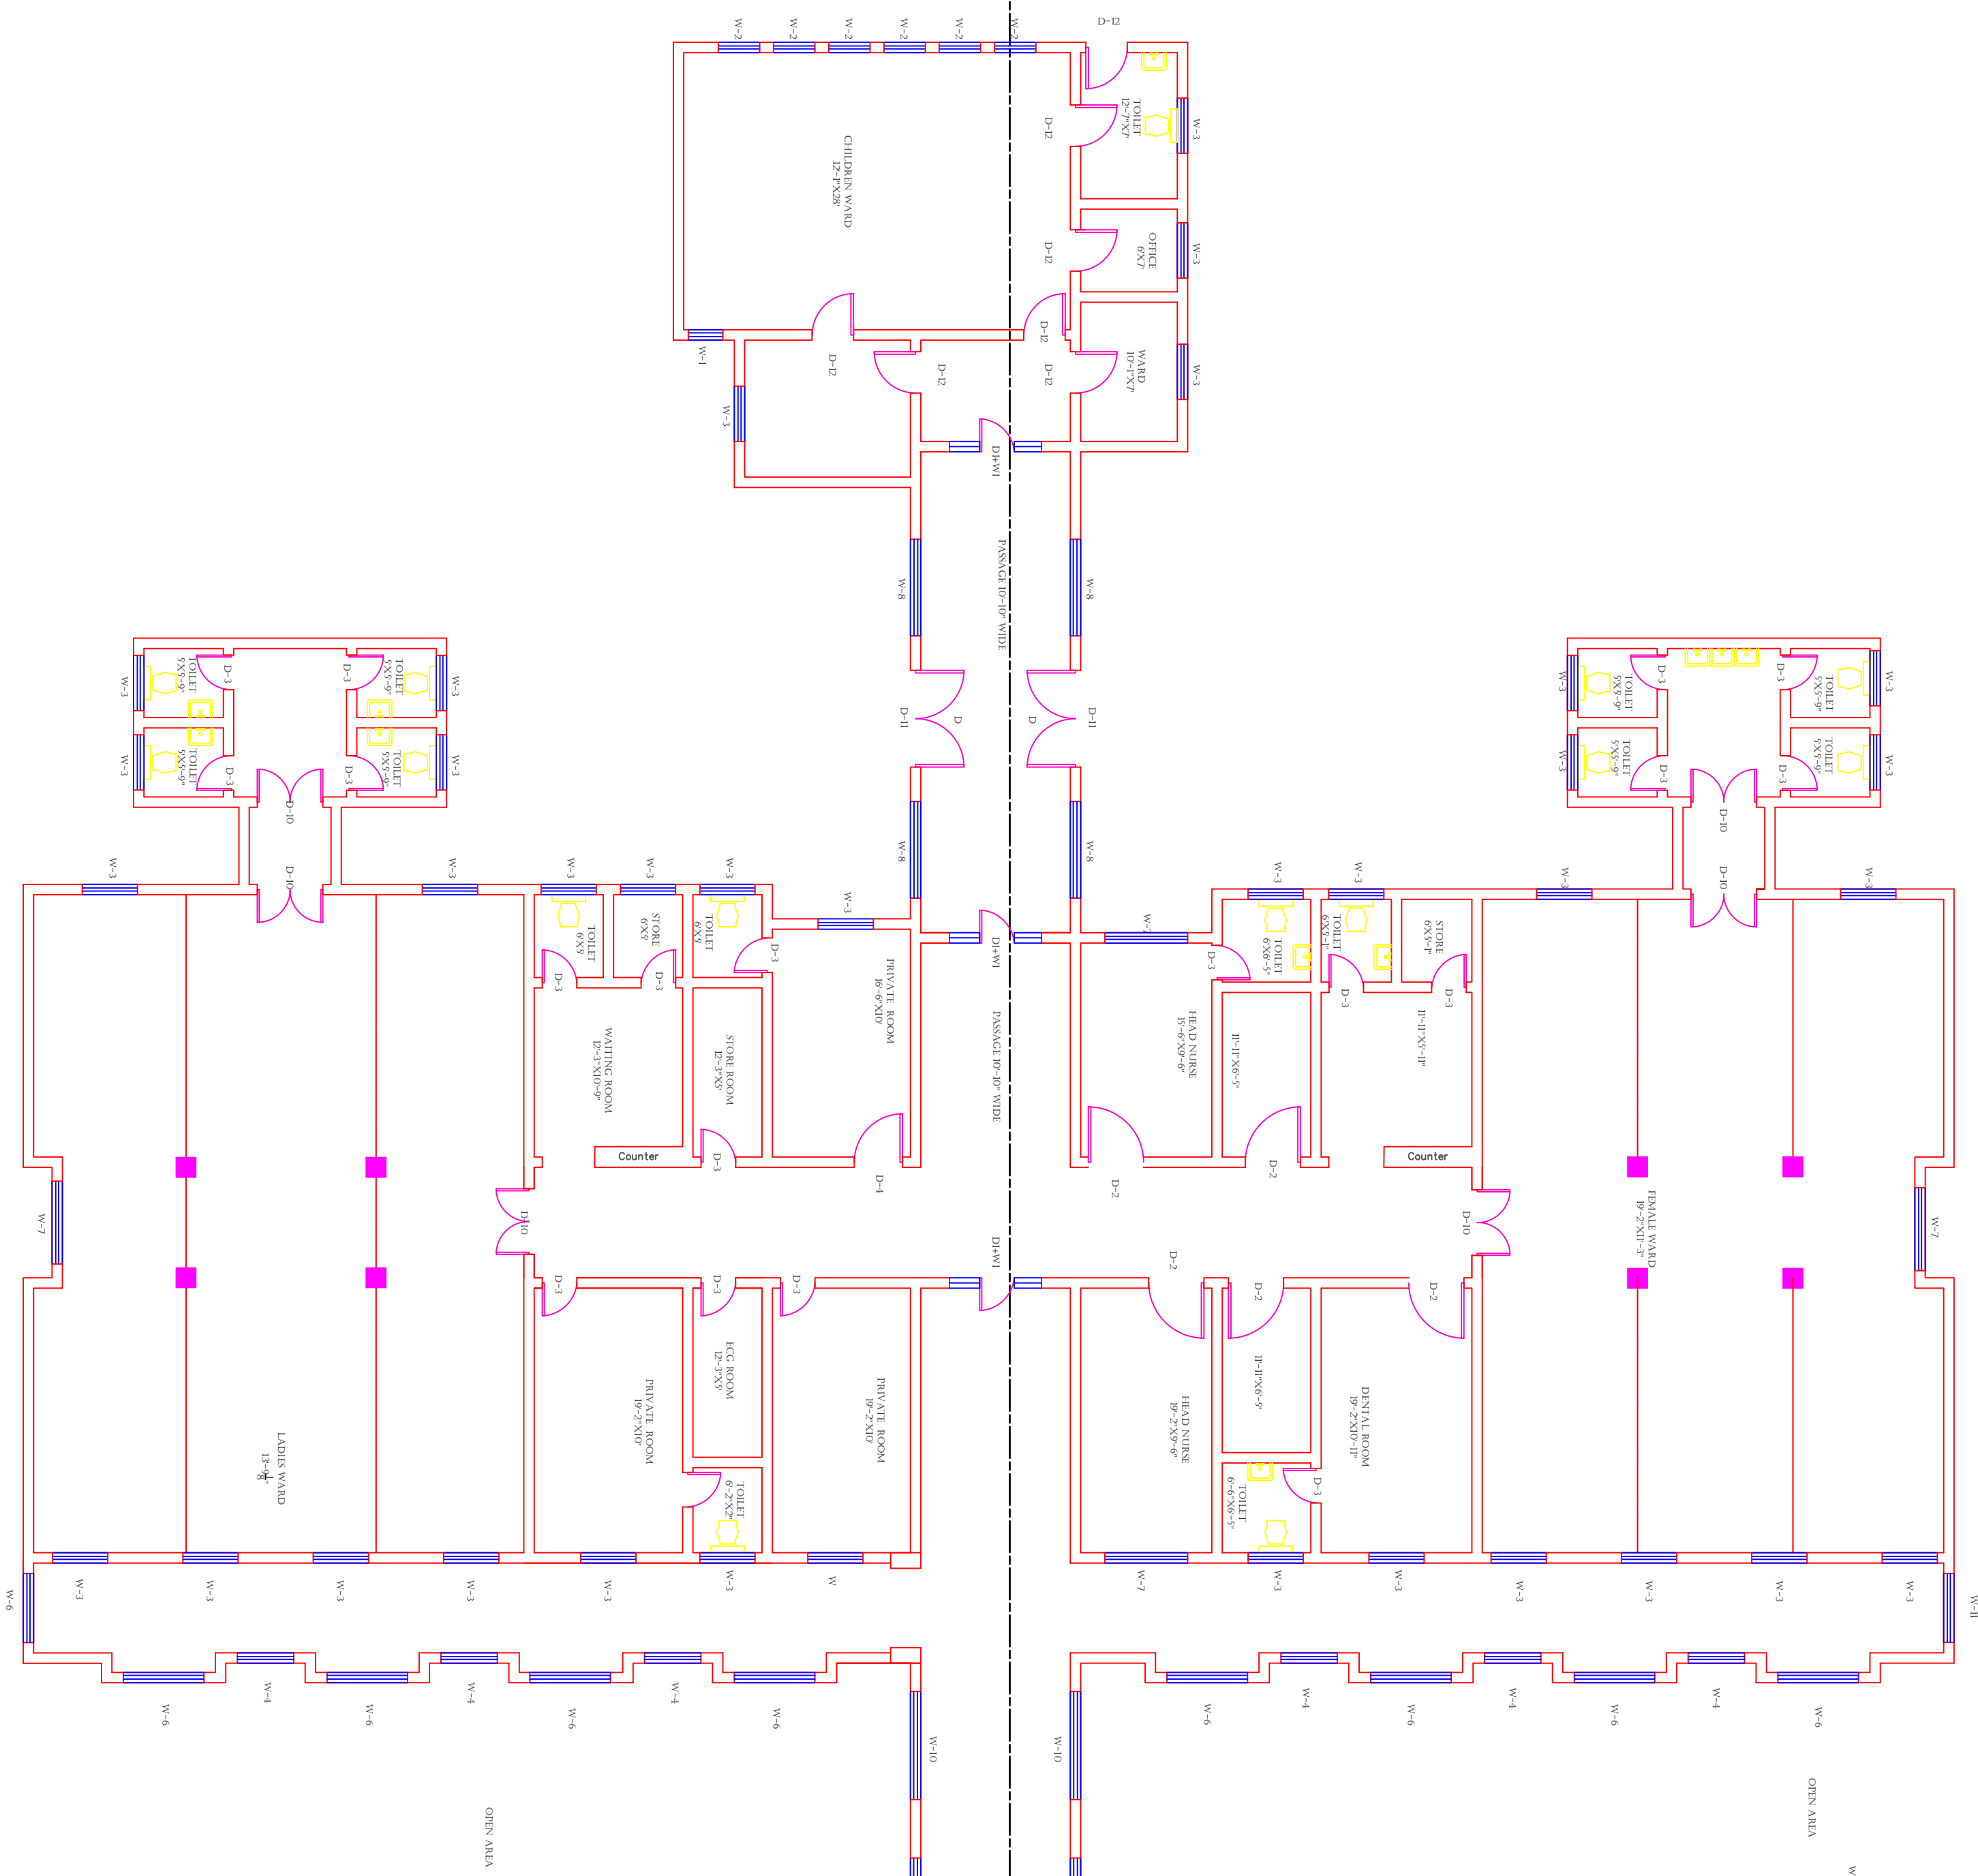PART 2



PART 3

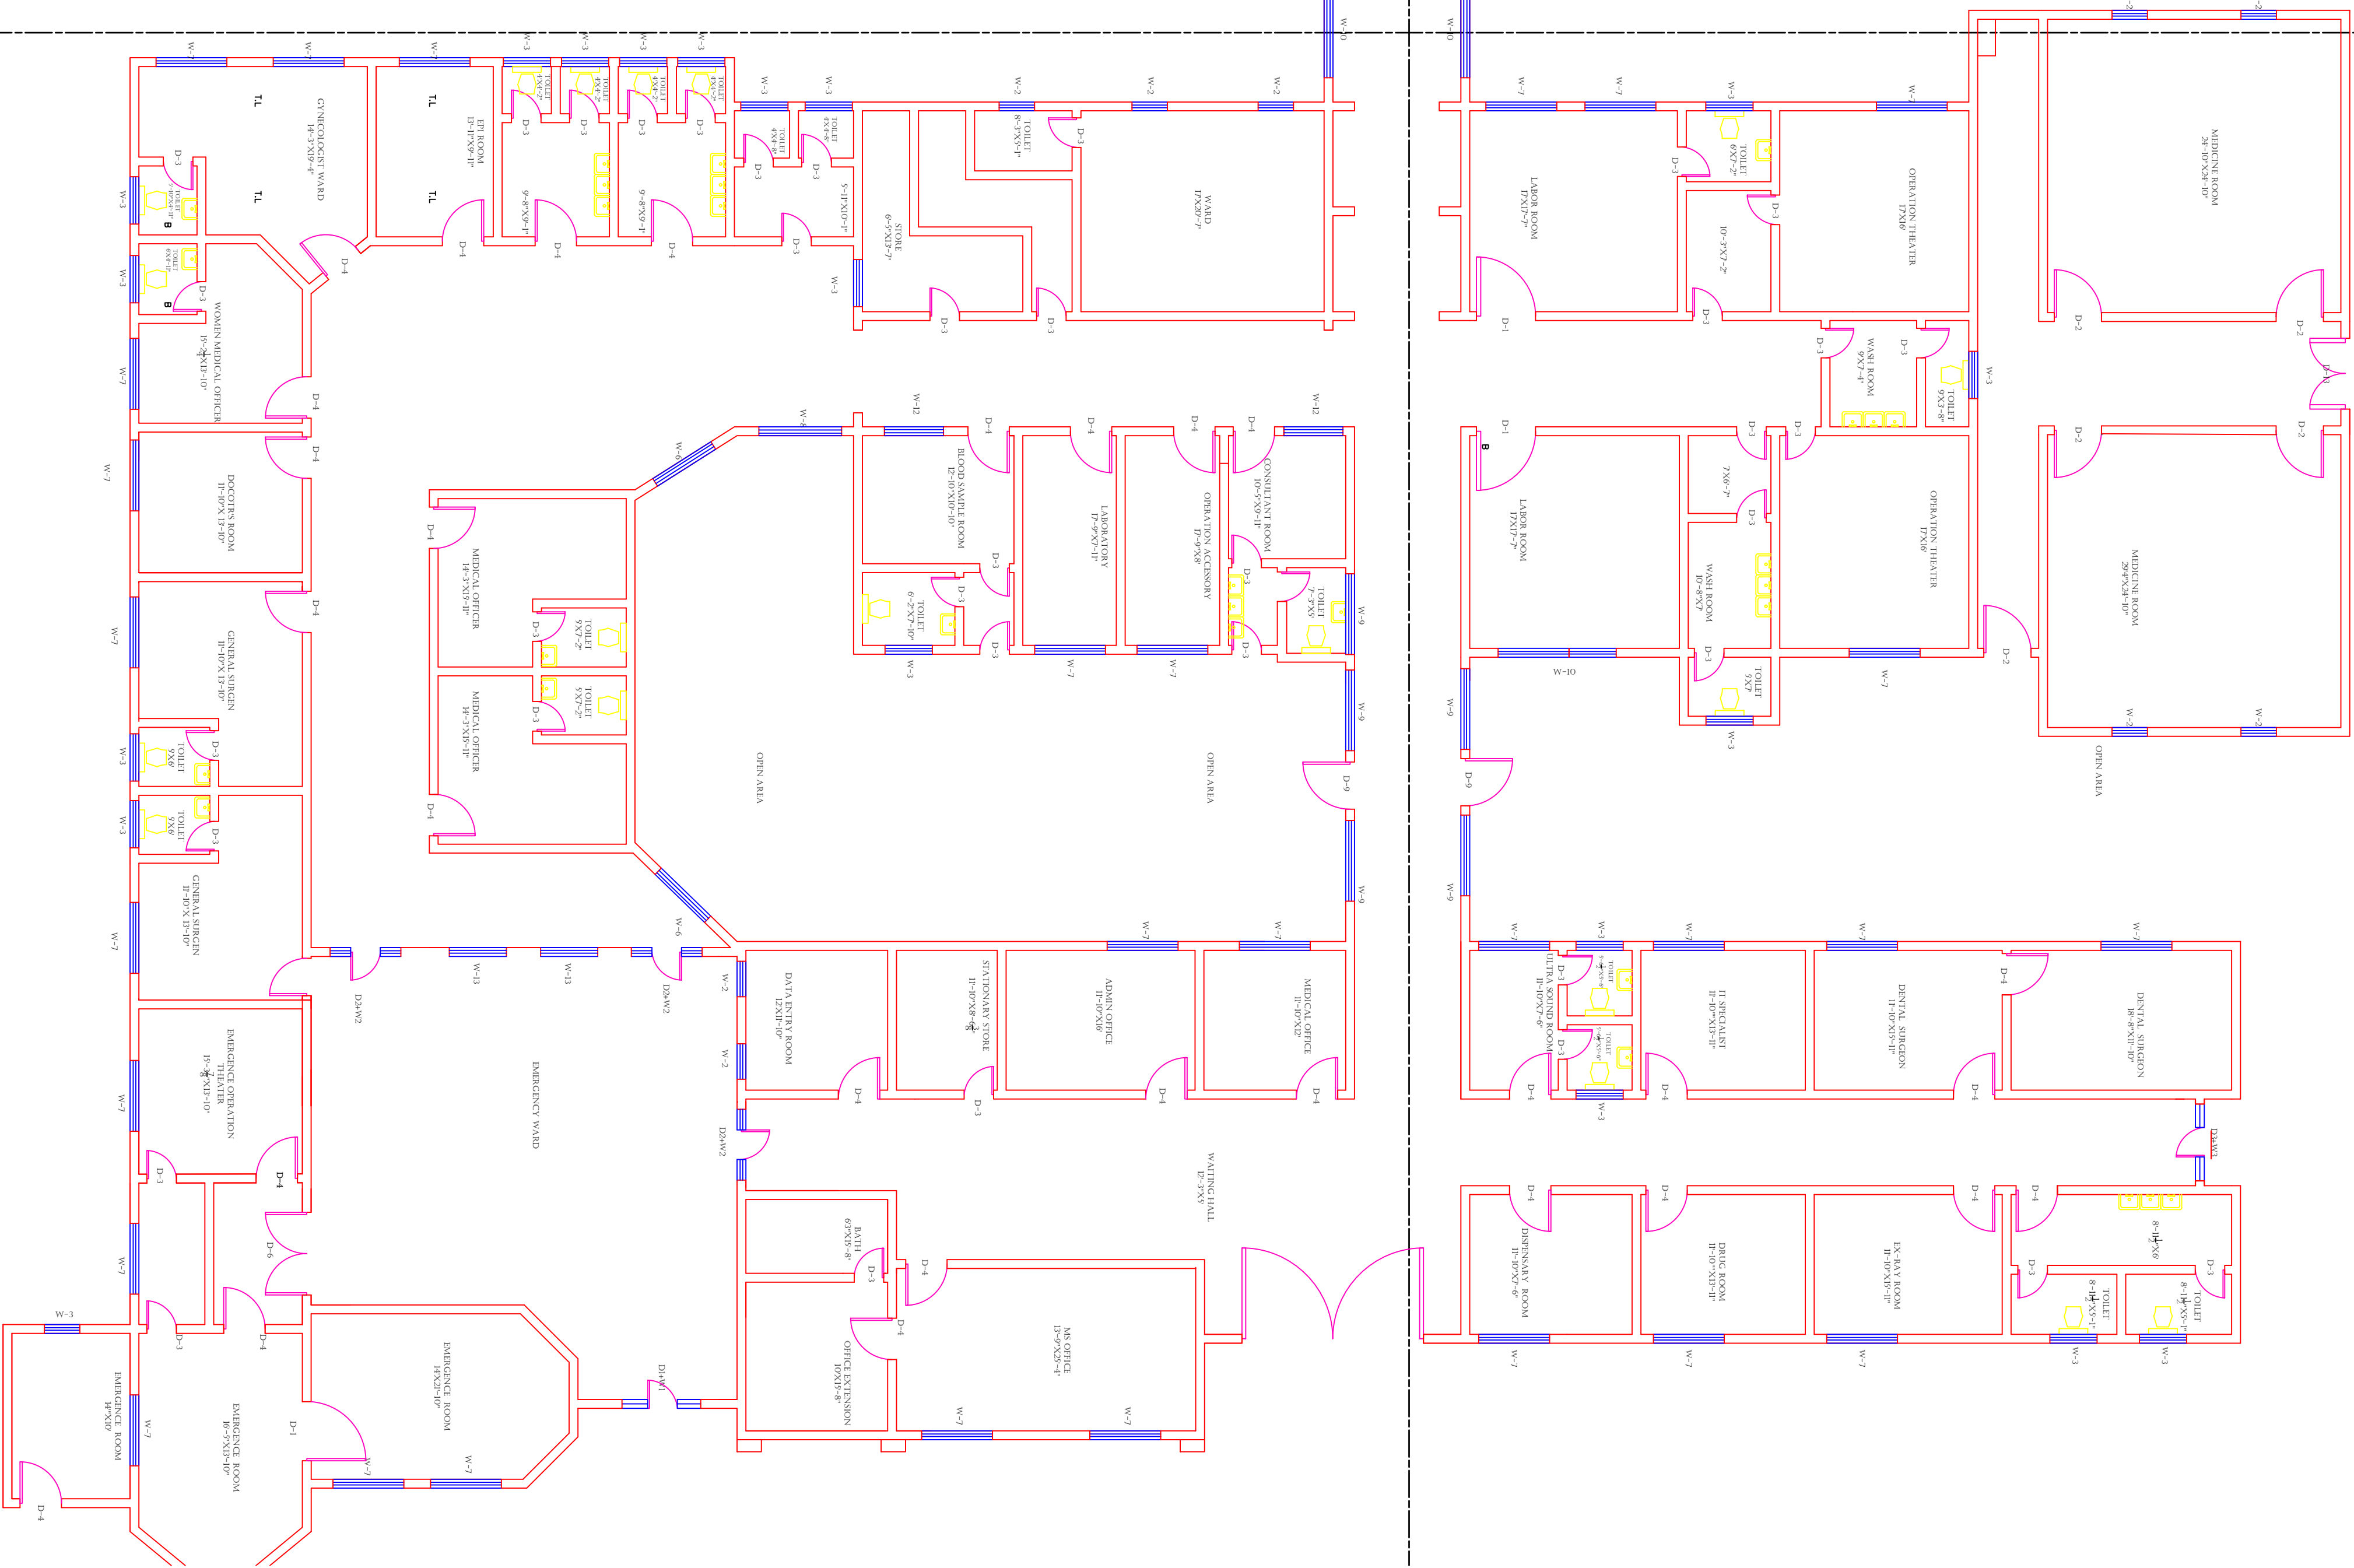PART 4



Legends:

RESIDENTIAL AREA	
ROAD	
WALL	
POWER LINE	
OHT	
TREE	
MANHOLE	
TUBE WELL	
LIGHT POLE	
LAWNS	
EARTHEN AREAS	
ASPHALT'S ROADS	
TOUGH PAVERS	
P.C.C /PLINTH PROTECTION	
BOUNDARY WALL	
TAP	
HAND PUMP	
BRICK PAVERS	
AIR CONDITIONER	
TUBE LIGHT	
FAN	
ROOF LIGHT	
BULB	

AREA	
AREA WITHIN BOUNDARY WALL	236746.91 SFT
AREA OF CLINICAL BLOCK	29746.37 SFT
PLINTH AREA OF BLOCK	SFT

OPENING SCHEDULE OF DOORS AND WINDOWS					
DOORS	WIDTH	HEIGHT	WINDOWS	WIDTH	HEIGHT
D1	5'-0"	7'-0"	W1	2'-6"	2'-6"
D2	4'-0"	7'-0"	W2	3'-0"	3'-0"
D3	2'-6"	7'-0"	W3	4'-0"	4'-0"
D4	3'-6"	7'-0"	W4	5'-0"	5'-0"
D5	6'-0"	7'-0"	W5	4'-6"	4'-6"
D6	7'-0"	7'-0"	W6	5'-10"	5'-10"
D7	12'-0"	7'-0"	W7	6'-0"	6'-0"
D8	4'-6"	7'-0"	W8		
D9	10'-0"	7'-0"	V2		

Client:



**GOVERNMENT OF THE PUNJAB
PRIMARY & SECONDARY
HEALTHCARE DEPARTMENT**

Project:

**CAD MAPPING OF TEHSIL
HEAD QUARTER HOSPITALS,
PUNJAB**

Consultant:



**SKAFS CONSULTANT (Pvt.) Limited
ENGINEERING AND ENVIRONMENT CONSULTANT**


Drawing Title:

**THQ PINDI BHATTIAN
HOSPITAL MAIN BUILDING
CLINICAL BLOCK PLAN**

Authorized By: SKAFS	Reviewed By Co-Team Leader	Scale: 1:350
Prepared By: CAD TEAMS	Date: FEB, 2017	
Drawing No. SKAFS/PINDI BHATTIAN /08		

CLINICAL BLOCK OF THQ HOSPITAL PINDI BHATTIYAN

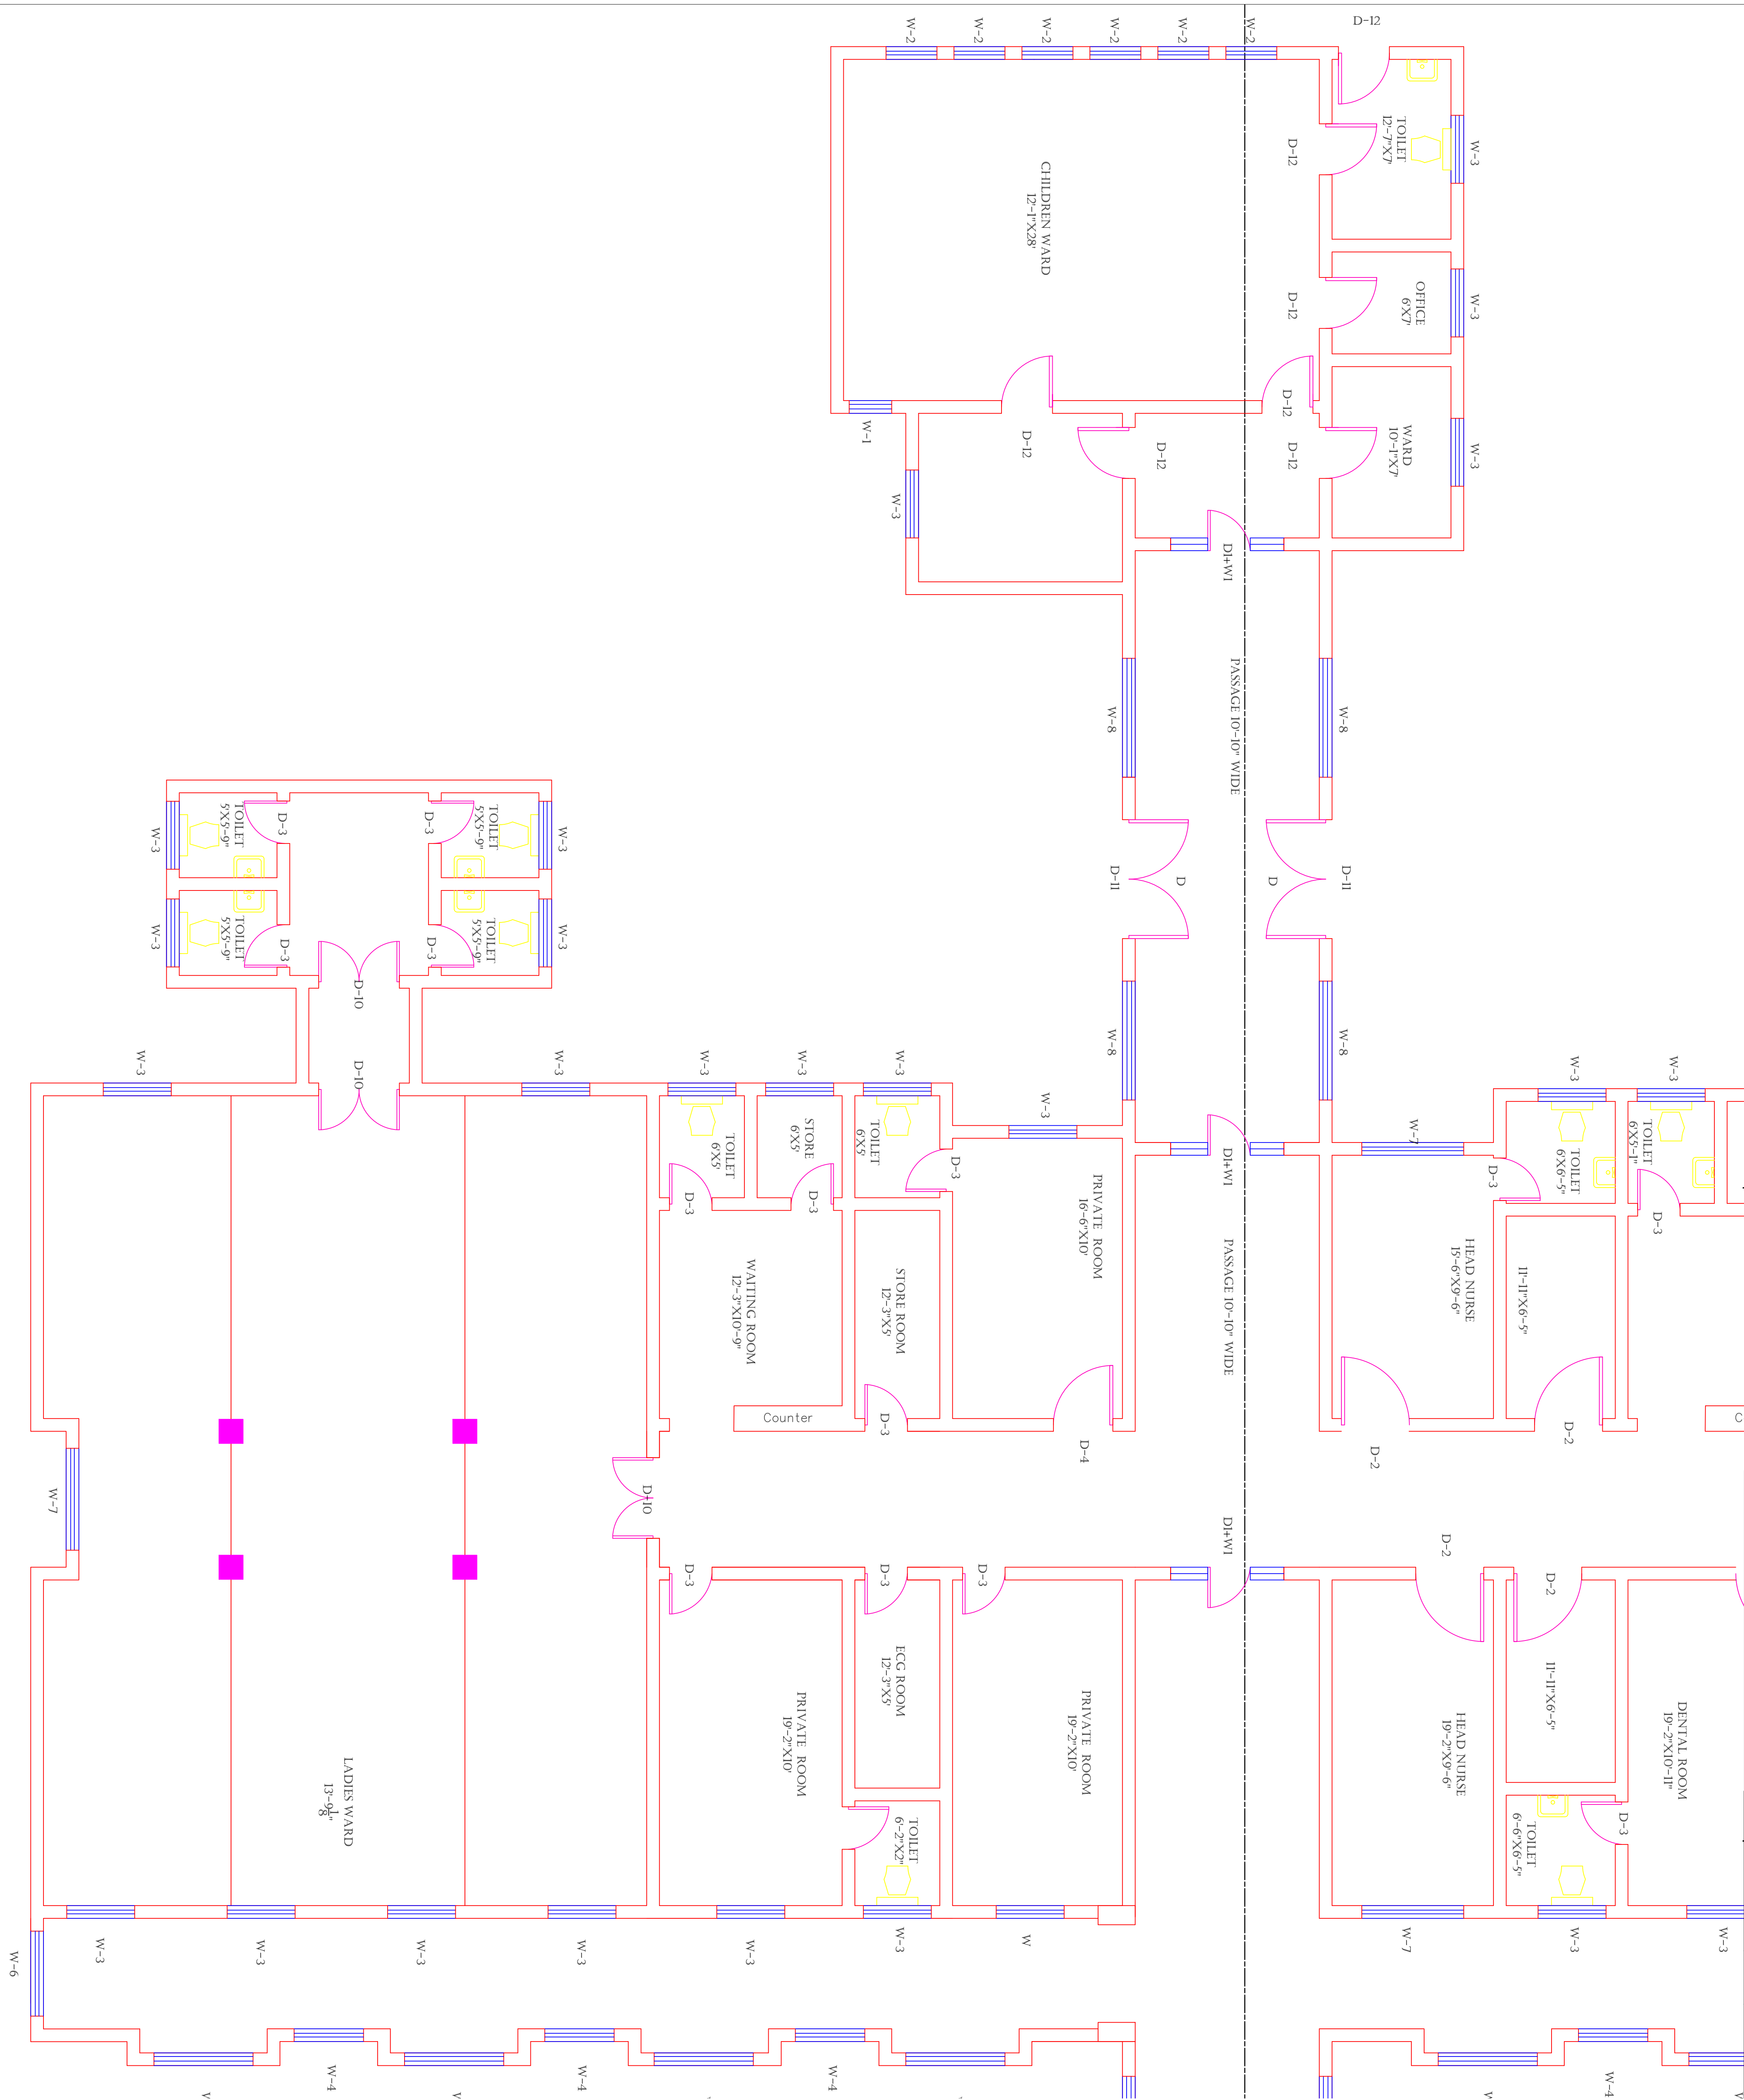GROUND FLOOR (PART 1)



Legends:

RESIDENTIAL AREA	
ROAD	
WALL	
POWER LINE	
OHT	
TREE	
MANHOLE	
TUBE WELL	
LIGHT POLE	
LAWNS	
EARTHEN AREAS	
ASPHALTS ROADS	
TOUGH PAVERS	
P.C.C /PLINTH PROTECTION	
BOUNDARY WALL	
TAP	
HAND PUMP	
BRICK PAVERS	
AIR CONDITIONER	
TUBE LIGHT	
FAN	
ROOF LIGHT	
BULB	

AREA	
AREA WITHIN BOUNDARY WALL	236746.91 SFT
AREA OF CLINICAL BLOCK	29746.37 SFT
PLINTH AREA OF BLOCK	SFT

OPENING SCHEDULE OF DOORS AND WINDOWS					
DOORS	WIDTH	HEIGHT	WINDOWS	WIDTH	HEIGHT
D1	5'-0"	7'-0"	W1	2'-6"	2'-6"
D2	4'-0"	7'-0"	W2	3'-0"	3'-0"
D3	2'-6"	7'-0"	W3	4'-0"	4'-0"
D4	3'-6"	7'-0"	W4	5'-0"	5'-0"
D5	6'-0"	7'-0"	W5	4'-6"	4'-6"
D6	7'-0"	7'-0"	W6	5'-10"	5'-10"
D7	12'-0"	7'-0"	W7	6'-0"	6'-0"
D8	4'-6"	7'-0"	W8		
D9	10'-0"	7'-0"	V2		

Client:

GOVERNMENT OF THE PUNJAB
PRIMARY & SECONDARY
HEALTHCARE DEPARTMENT

Project:

CAD MAPPING OF TEHSIL
HEAD QUARTER HOSPITALS,
PUNJAB

Consultant:

SKAFS CONSULTANT (Pvt.) Limited
ENGINEERING AND ENVIRONMENT CONSULTANT

Drawing Title:


THQ PINDI BHATTIAN
HOSPITAL CLINICAL BLOCK
PART 1

Authorized By: SKAFS	Reviewed By Co-Team Leader	Scale:
Prepared By: CAD TEAMS	Date: FEB, 2017	


Drawing No.

SKAFS/PINDI BHATTIAN/09

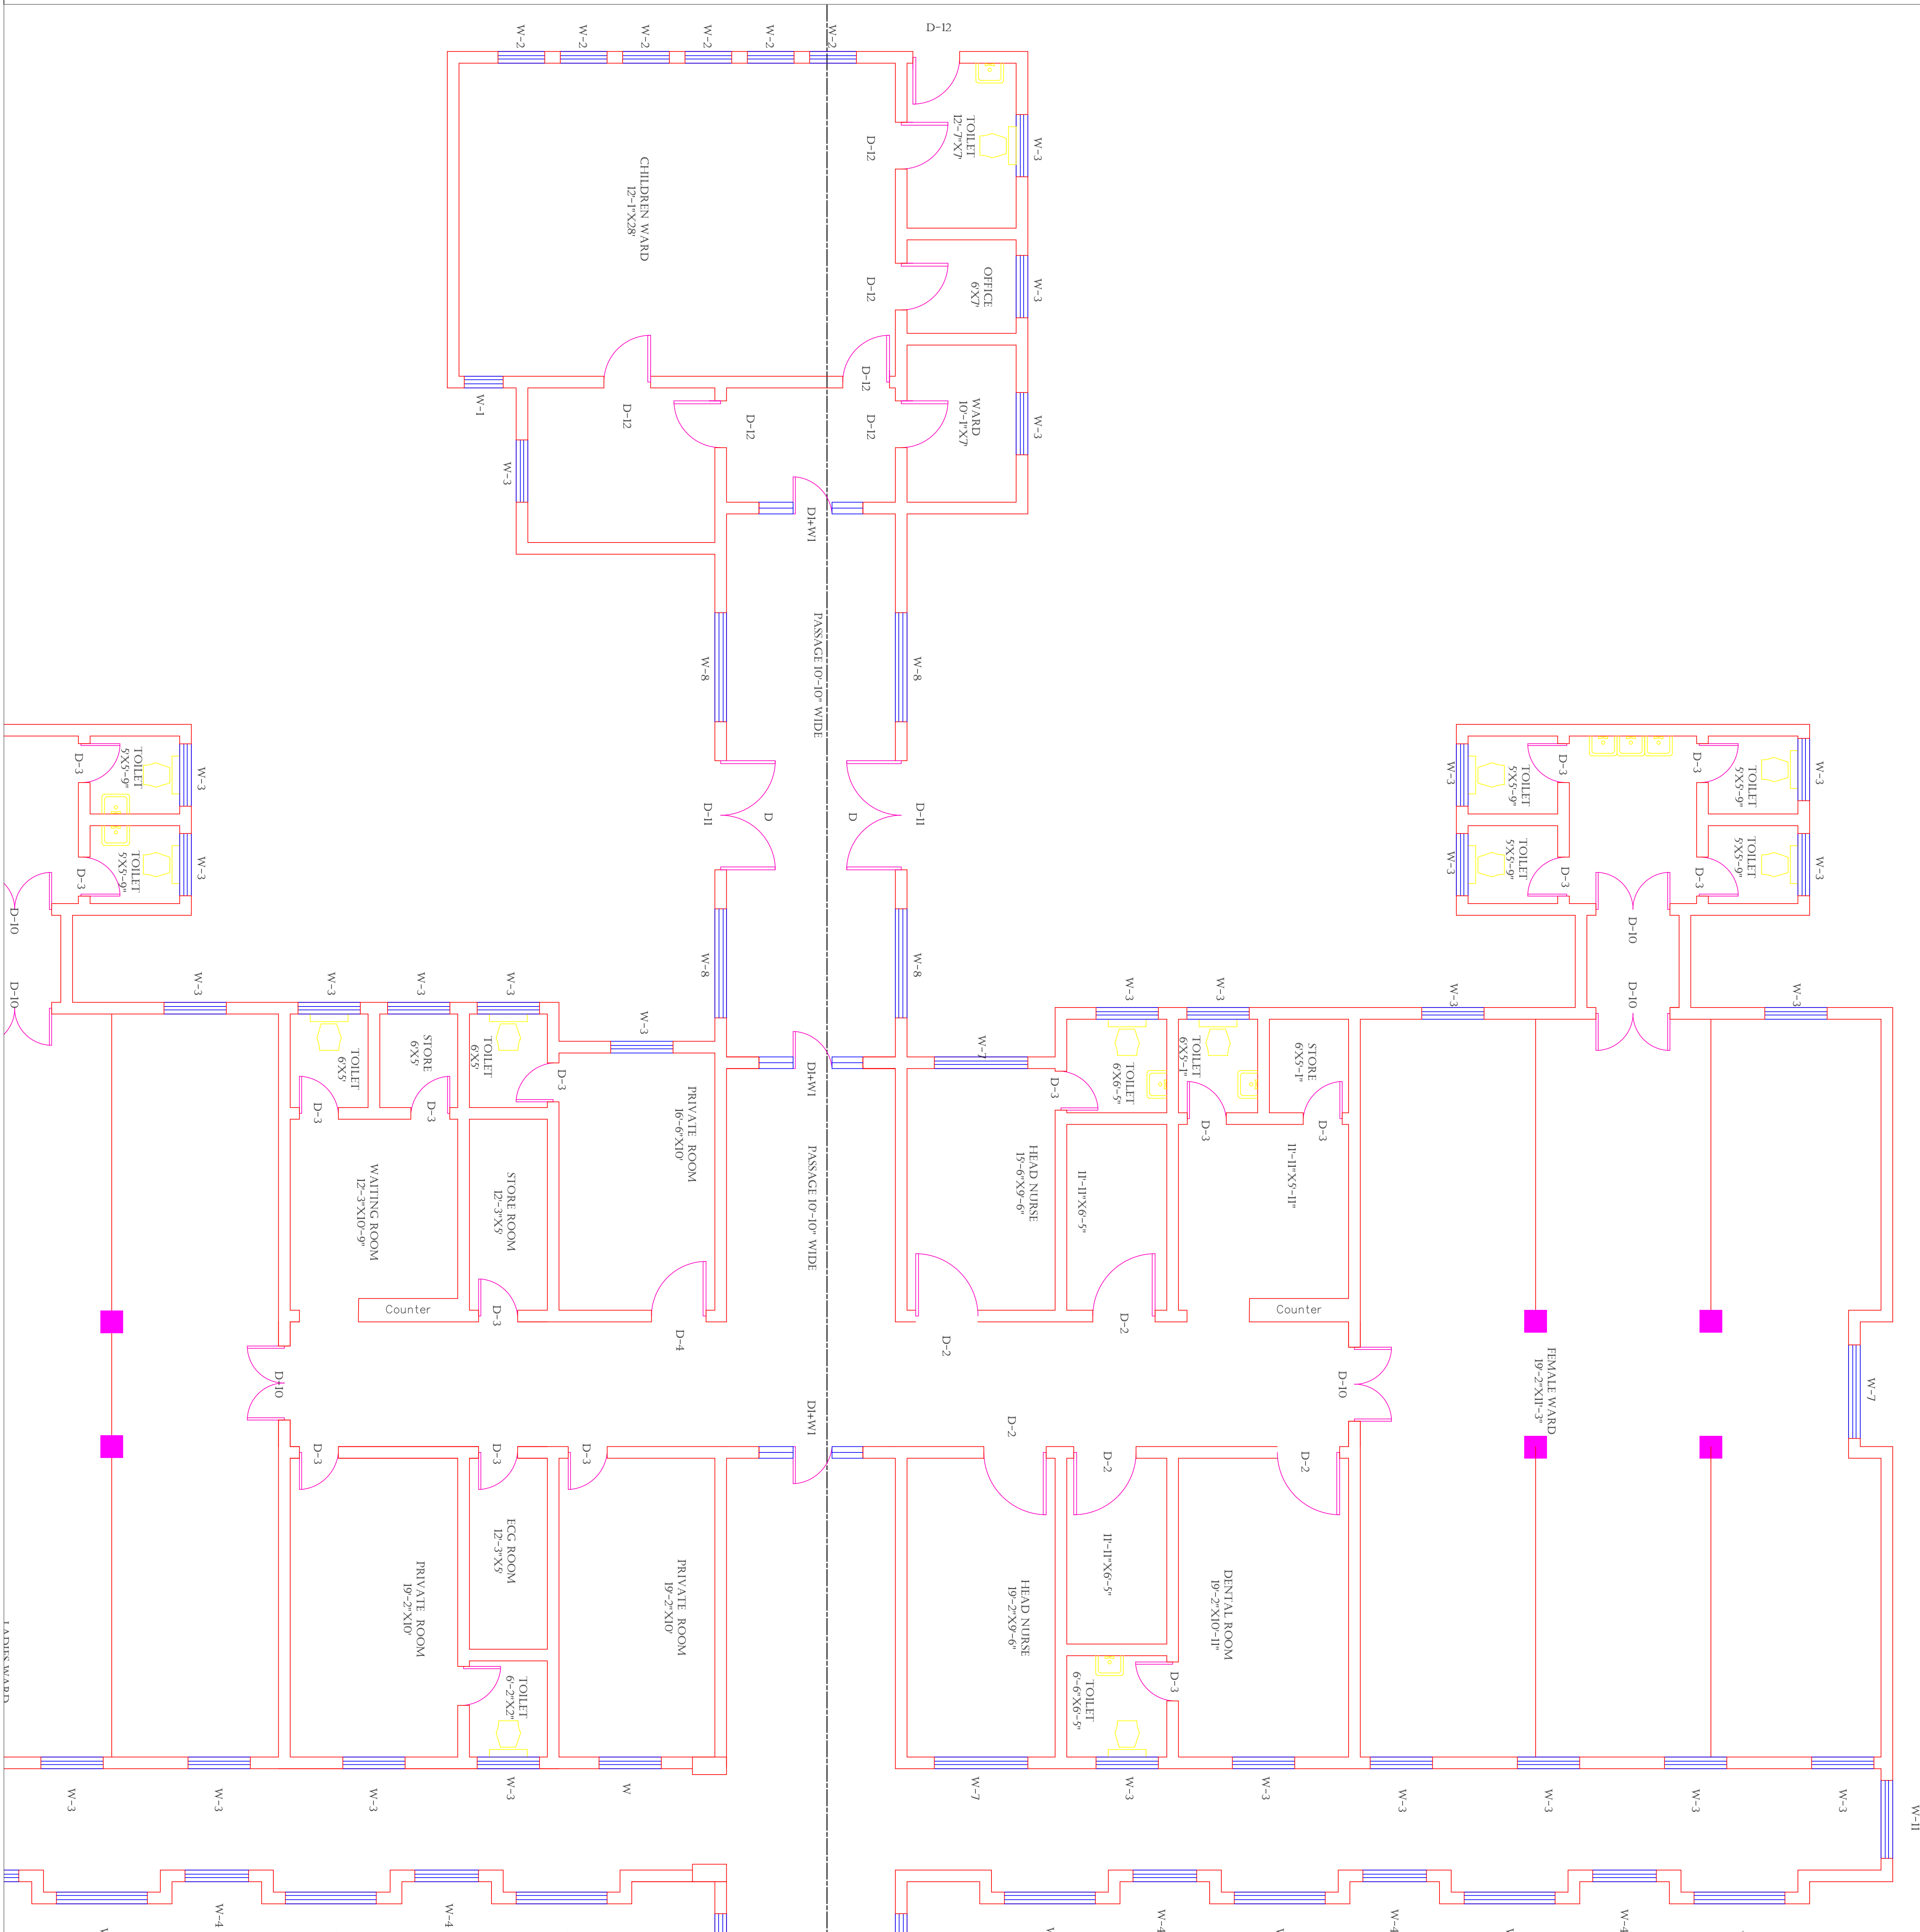CLINICAL BLOCK OF THQ HOSPITAL PINDI BHATTIYAN
GROUND FLOOR (PART 2)



Legends:

 RESIDENTIAL AREA	
ROAD	
WALL	
POWER LINE	
OHT	
TREE	
MANHOLE	
TUBE WELL	
LIGHT POLE	
LAWNS	
EARTHEN AREAS	
ASPHALT'S ROADS	
TOUGH PAVERS	
P.C.C /PLINTH PROTECTION	
BOUNDARY WALL	
TAP	
HAND PUMP	
BRICK PAVERS	
AIR CONDITIONER	
TUBE LIGHT	
FAN	
ROOF LIGHT	
BULB	

AREA	
AREA WITHIN BOUNDARY WALL	236746.91 SFT
AREA OF CLINICAL BLOCK	29746.37 SFT
PLINTH AREA OF BLOCK	SFT

OPENING SCHEDULE OF DOORS AND WINDOWS					
DOORS	WIDTH	HEIGHT	WINDOWS	WIDTH	HEIGHT
D1	5'-0"	7'-0"	W1	2'-6"	2'-6"
D2	4'-0"	7'-0"	W2	3'-0"	3'-0"
D3	2'-6"	7'-0"	W3	4'-0"	4'-0"
D4	3'-6"	7'-0"	W4	5'-0"	5'-0"
D5	6'-0"	7'-0"	W5	4'-6"	4'-6"
D6	7'-0"	7'-0"	W6	5'-10"	5'-10"
D7	12'-0"	7'-0"	W7	6'-0"	6'-0"
D8	4'-6"	7'-0"	W8		
D9	10'-0"	7'-0"	V2		

Client:



**GOVERNMENT OF THE PUNJAB
PRIMARY & SECONDARY
HEALTHCARE DEPARTMENT**

Project:

CAD MAPPING OF TEHSIL HEAD QUARTER HOSPITALS, PUNJAB

Consultant:




SKAFS CONSULTANT (Pvt.) Limited
ENGINEERING AND ENVIRONMENT CONSULTANT

Drawing Title:
**THQ PINDI BHATTIAN
HOSPITAL CLINICAL BLOCK
PART 2**

Authorized By: SKAFS	Reviewed By Co-Team Leader	Scale:
Prepared By: CAD TEAMS	Date: FEB, 2017	
Drawing No. SKAFS/PINDI BHATTIAN /10		

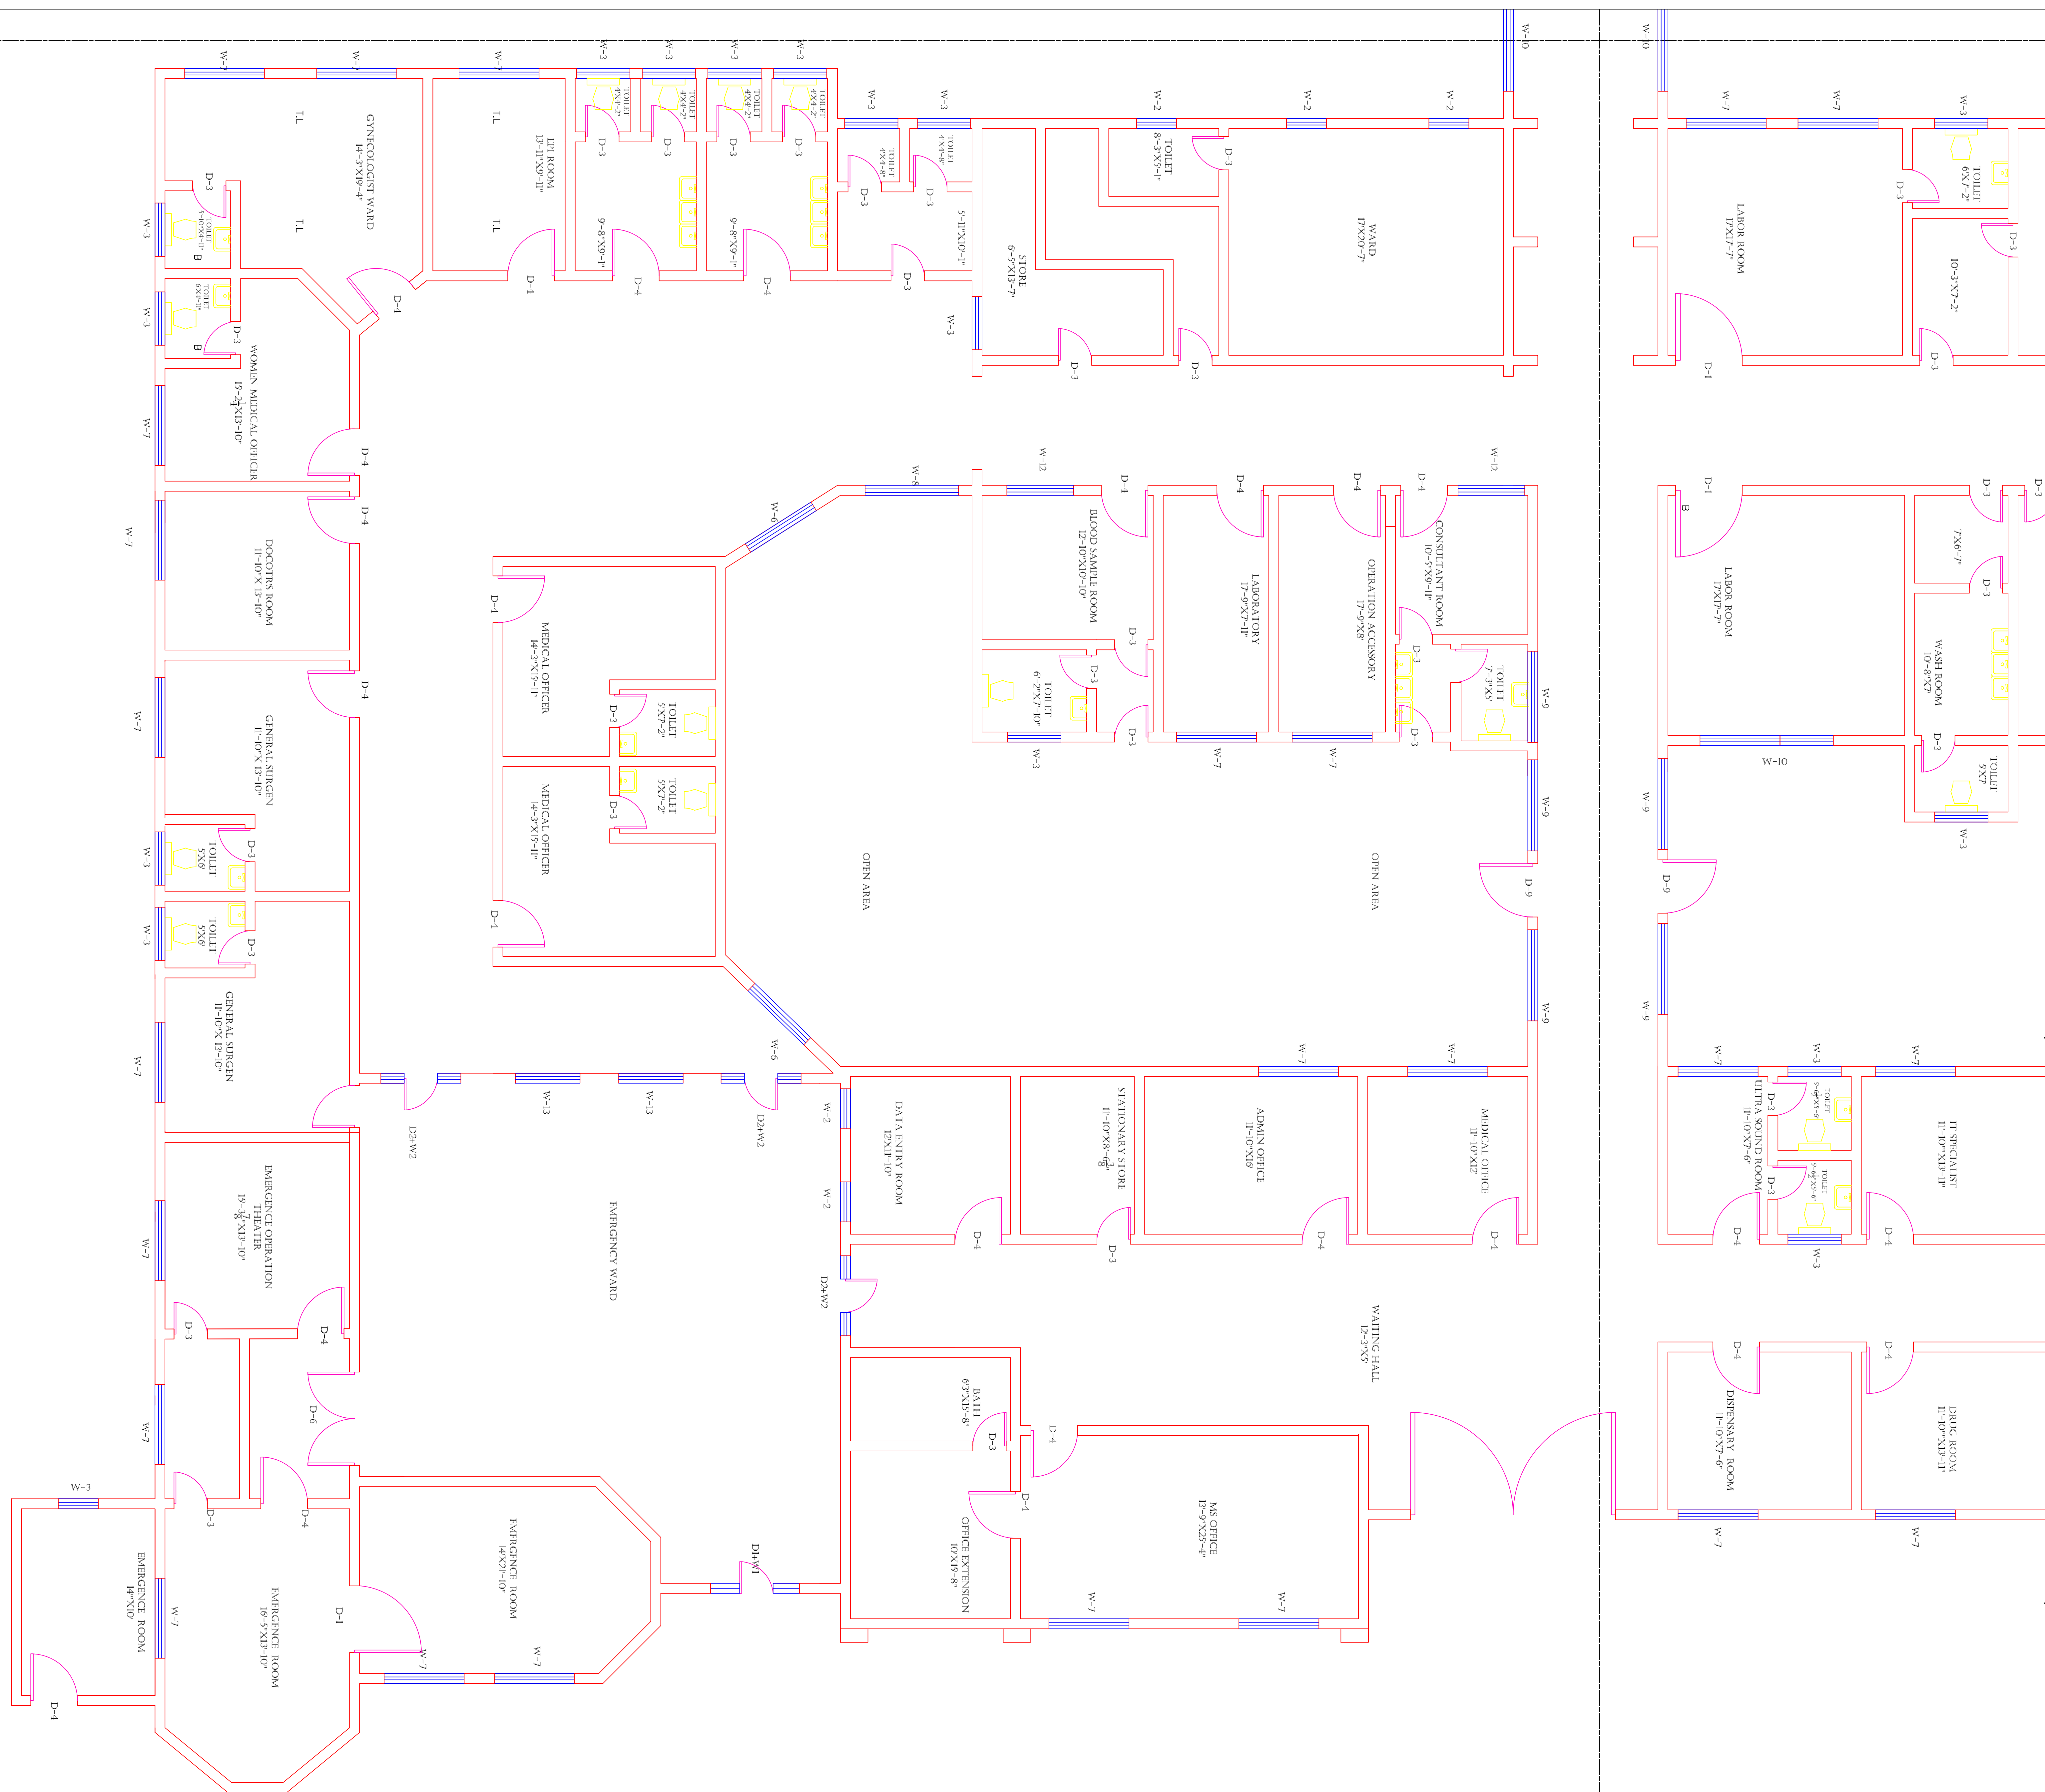CLINICAL BLOCK OF THQ HOSPITAL PINDI BHATTIYAN
GROUND FLOOR (PART 3)



Legends:	
RESIDENTIAL AREA	
ROAD	
WALL	
POWER LINE	
OHT	
TREE	
MANHOLE	
TUBE WELL	
LIGHT POLE	
LAWNS	
EARTHEN AREAS	
ASPHALTS ROADS	
TOUGH PAVERS	
P.C.C /PLINTH PROTECTION	
BOUNDARY WALL	
TAP	
HAND PUMP	
BRICK PAVERS	
AIR CONDITIONER	
TUBE LIGHT	
FAN	
ROOF LIGHT	
BULB	

AREA	
AREA WITHIN BOUNDARY WALL	236746.91 SFT
AREA OF CLINICAL BLOCK	29746.37 SFT
PLINTH AREA OF BLOCK	SFT

OPENING SCHEDULE OF DOORS AND WINDOWS					
DOORS	WIDTH	HEIGHT	WINDOWS	WIDTH	HEIGHT
D1	5'-0"	7'-0"	W1	2'-6"	2'-6"
D2	4'-0"	7'-0"	W2	3'-0"	3'-0"
D3	2'-6"	7'-0"	W3	4'-0"	4'-0"
D4	3'-6"	7'-0"	W4	5'-0"	5'-0"
D5	6'-0"	7'-0"	W5	4'-6"	4'-6"
D6	7'-0"	7'-0"	W6	5'-10"	5'-10"
D7	12'-0"	7'-0"	W7	6'-0"	6'-0"
D8	4'-6"	7'-0"	W8		
D9	10'-0"	7'-0"	V2		

Client:

**GOVERNMENT OF THE PUNJAB
PRIMARY & SECONDARY
HEALTHCARE DEPARTMENT**

Project:

CAD MAPPING OF TEHSIL
HEAD QUARTER HOSPITALS,
PUNJAB

Consultant:

SKAFS CONSULTANT (Pvt.) Limited
ENGINEERING AND ENVIRONMENT CONSULTANT

Drawing Title:


THQ PINDI BHATTIAN
HOSPITAL CLINICAL BLOCK
PART 3

Authorized By: SKAFS	Reviewed By Co-Team Leader	Scale:
Prepared By: CAD TEAMS	Date: FEB, 2017	

Drawing No. SKAFS/PINDI BHATTIAN /11

CLINICAL BLOCK OF THQ HOSPITAL PINDI BHATTIYAN

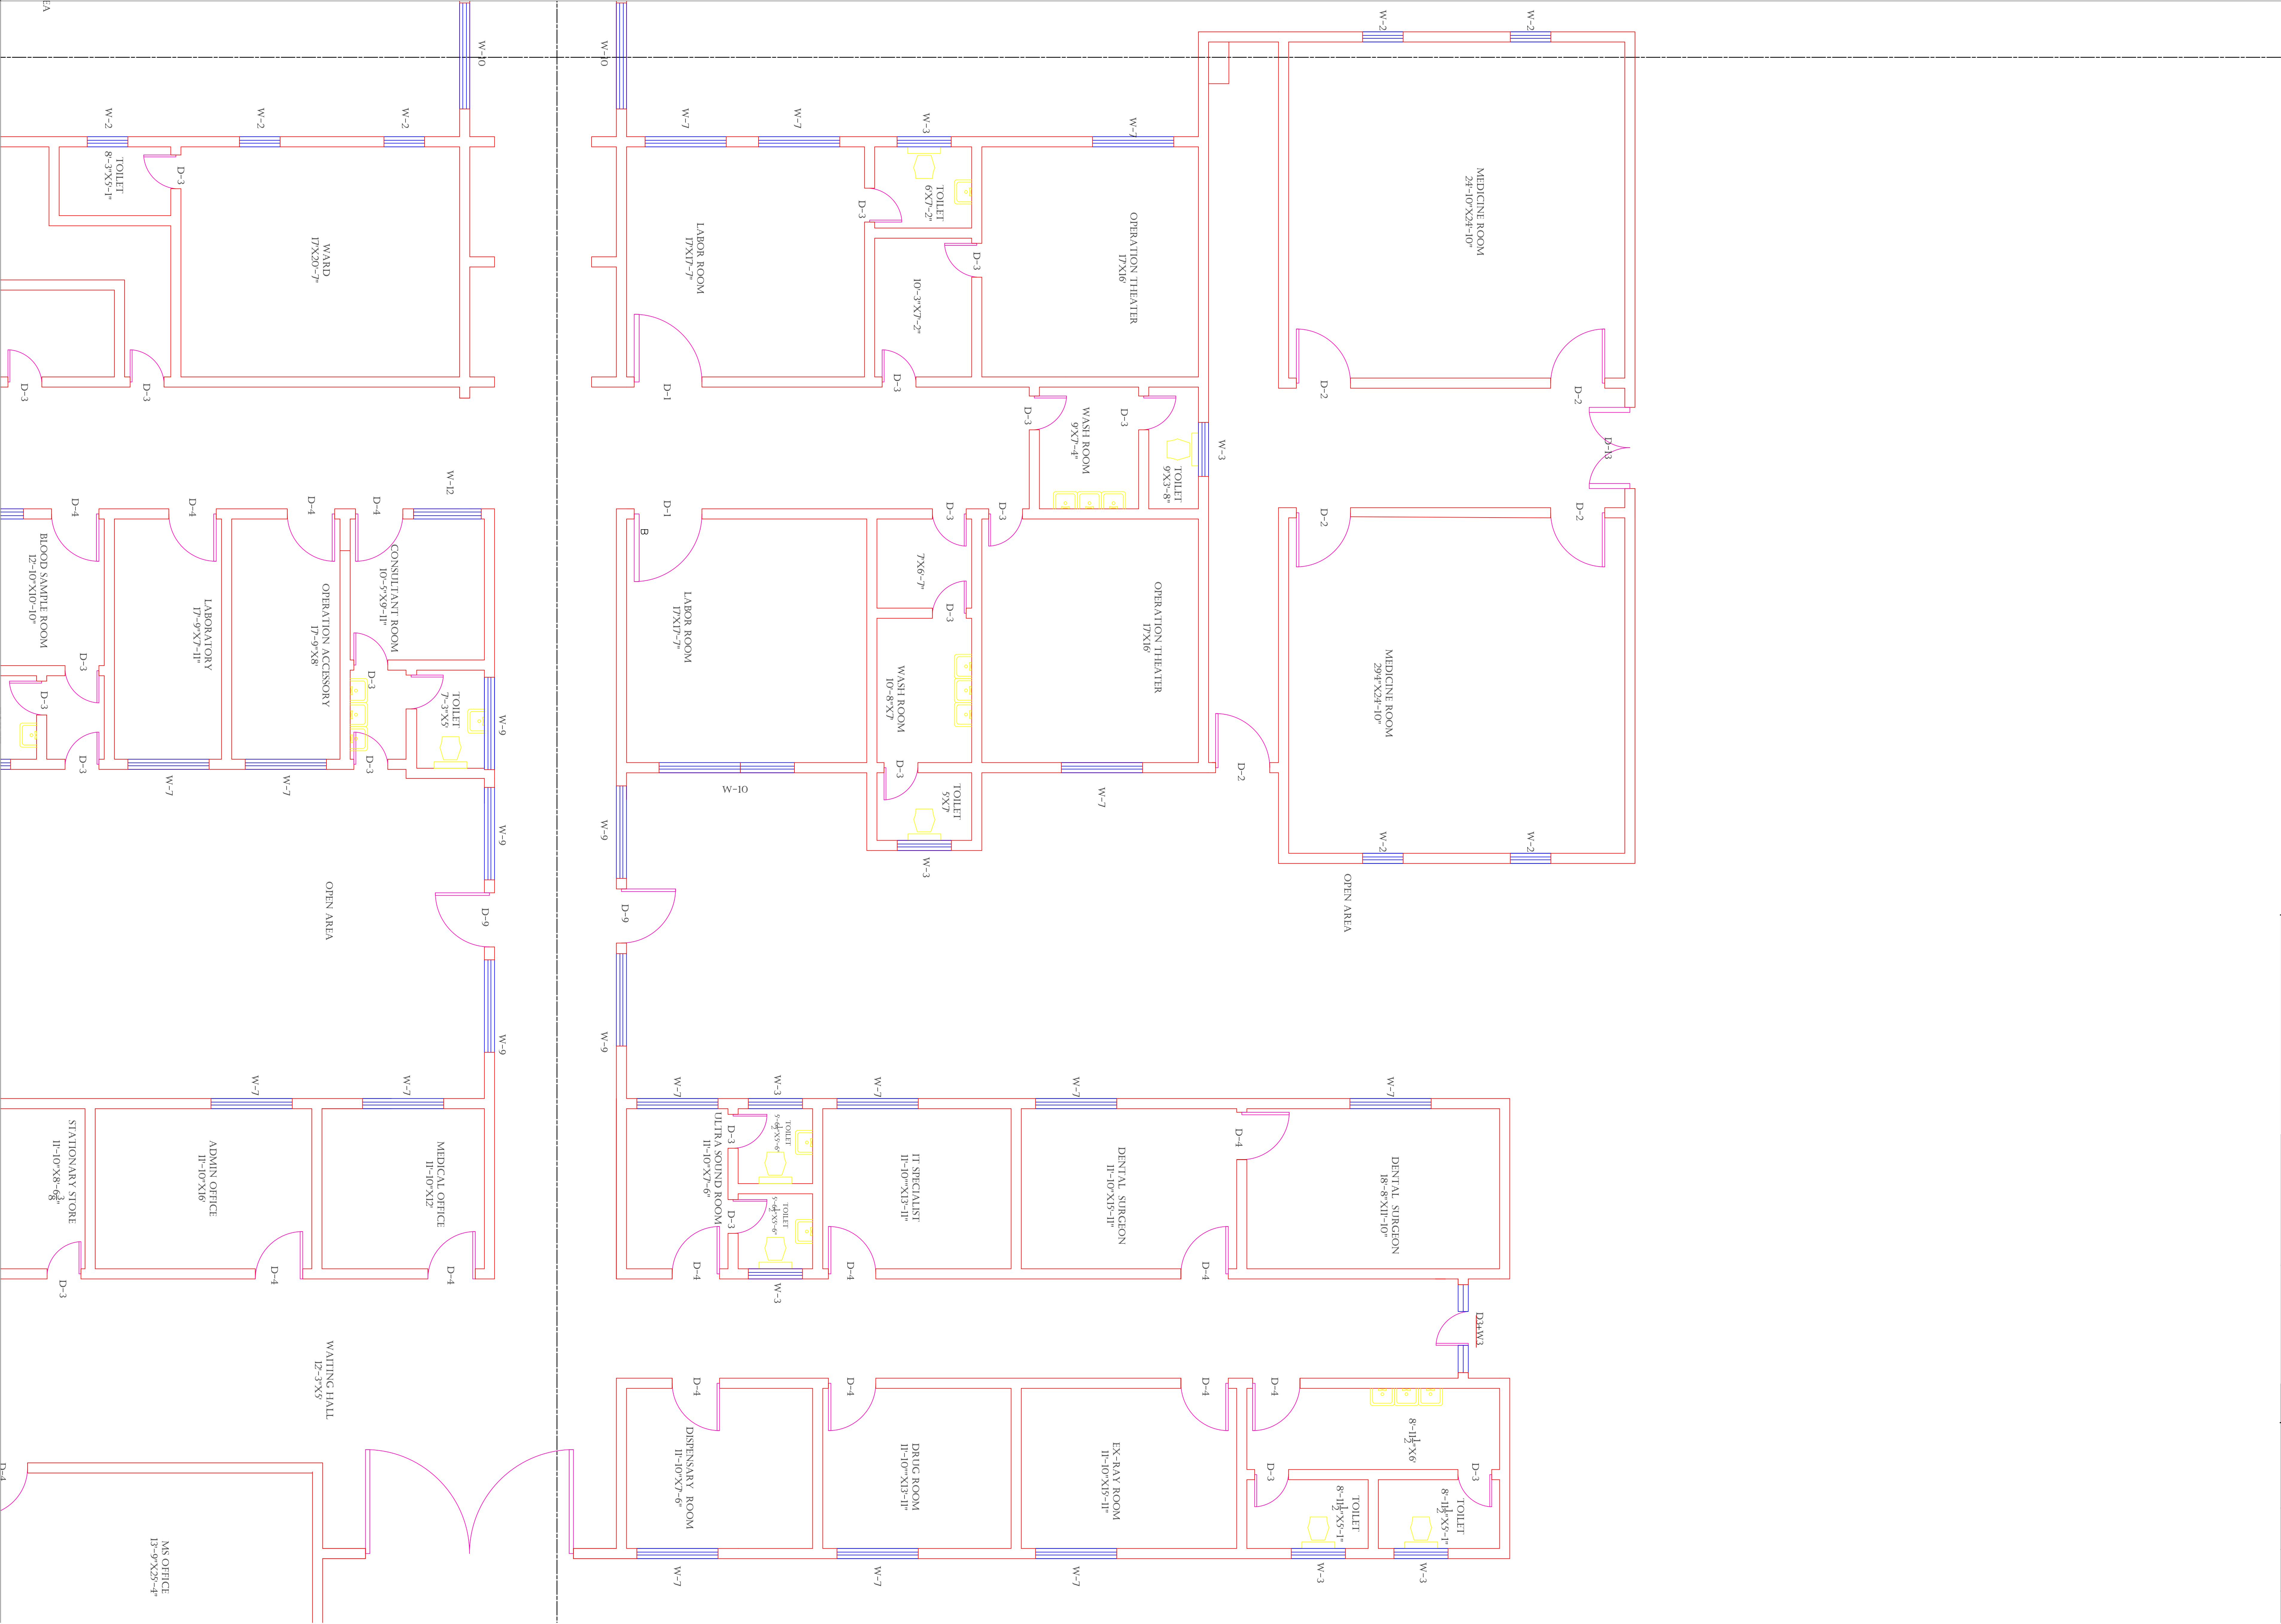GROUND FLOOR (PART 4)



Legends:

RESIDENTIAL AREA	
ROAD	
WALL	
POWER LINE	
OHT	
TREE	
MANHOLE	
TUBE WELL	
LIGHT POLE	
LAWNS	
EARTHEN AREAS	
ASPHALTS ROADS	
TOUGH PAVERS	
P.C.C /PLINTH PROTECTION	
BOUNDARY WALL	
TAP	
HAND PUMP	
BRICK PAVERS	
AIR CONDITIONER	
TUBE LIGHT	
FAN	
ROOF LIGHT	
BULB	

AREA	
AREA WITHIN BOUNDARY WALL	236746.91 SFT
AREA OF CLINICAL BLOCK	29746.37 SFT
PLINTH AREA OF BLOCK	SFT

OPENING SCHEDULE OF DOORS AND WINDOWS					
DOORS	WIDTH	HEIGHT	WINDOWS	WIDTH	HEIGHT
D1	5'-0"	7'-0"	W1	2'-6"	2'-6"
D2	4'-0"	7'-0"	W2	3'-0"	3'-0"
D3	2'-6"	7'-0"	W3	4'-0"	4'-0"
D4	3'-6"	7'-0"	W4	5'-0"	5'-0"
D5	6'-0"	7'-0"	W5	4'-6"	4'-6"
D6	7'-0"	7'-0"	W6	5'-10"	5'-10"
D7	12'-0"	7'-0"	W7	6'-0"	6'-0"
D8	4'-6"	7'-0"	W8		
D9	10'-0"	7'-0"	V2		

Client:

GOVERNMENT OF THE PUNJAB
PRIMARY & SECONDARY
HEALTHCARE DEPARTMENT

Project:

CAD MAPPING OF TEHSIL
HEAD QUARTER HOSPITALS,
PUNJAB

Consultant:

SKAFS CONSULTANT (Pvt.) Limited
ENGINEERING AND ENVIRONMENT CONSULTANT

Drawing Title:

THQ PINDI BHATTIAN
HOSPITAL CLINICAL BLOCK
PART 4

Authorized By: SKAFS	Reviewed By Co-Team Leader	Scale:
Prepared By: CAD TEAMS	Date: FEB, 2017	

 
 
 
 
 
 
 
 
 
 
Drawing No.

SKAFS/PINDI BHATTIAN /12

ELECTRICAL LAYOUT PLAN OF THQ HOSPITAL PINDI BHATTIYAN GROUND FLOOR



Legends:

RESIDENTIAL AREA	
ROAD	
WALL	
POWER LINE	
OHT	
TREE	
MANHOLE	
TUBE WELL	
LIGHT POLE	
LAWNS	
EARTHEN AREAS	
ASPHALTS ROADS	
TOUGH PAVERS	
P.C.C /PLINTH PROTECTION	
BOUNDARY WALL	
TAP	
HAND PUMP	
BRICK PAVERS	
AIR CONDITIONER	
TUBE LIGHT	
FAN	
ROOF LIGHT	
BULB	

AREA	
AREA WITHIN BOUNDARY WALL	236746.91 SFT
AREA OF CLINICAL BLOCK	29746.37 SFT
PLINTH AREA OF BLOCK	SFT

OPENING SCHEDULE OF DOORS AND WINDOWS					
DOORS	WIDTH	HEIGHT	WINDOWS	WIDTH	HEIGHT
D1	5'-0"	7'-0"	W1	2'-6"	2'-6"
D2	4'-0"	7'-0"	W2	3'-0"	3'-0"
D3	2'-6"	7'-0"	W3	4'-0"	4'-0"
D4	3'-6"	7'-0"	W4	5'-0"	5'-0"
D5	6'-0"	7'-0"	W5	4'-6"	4'-6"
D6	7'-0"	7'-0"	W6	5'-10"	5'-10"
D7	12'-0"	7'-0"	W7	6'-0"	6'-0"
D8	4'-6"	7'-0"	W8		
D9	10'-0"	7'-0"	V2		

Client:



GOVERNMENT OF THE PUNJAB
PRIMARY & SECONDARY
HEALTHCARE DEPARTMENT

Project:

CAD MAPPING OF TEHSIL HEAD QUARTER HOSPITALS, PUNJAB

Consultant:



SKAFS CONSULTANT (Pvt.) Limited
ENGINEERING AND ENVIRONMENT CONSULTANT

Drawing Title:

THQ PINDI BHATTIAN
ELECTRICAL LAYOUT
GROUND FLOOR

Authorized By: SKAFS	Reviewed By Co-Team Leader	Scale:
Prepared By: CAD TEAMS	Date: FEB, 2017	

Drawing No.

SKAFS/PINDI BHATTIAN /13