



MASTER PLAN OF THQ HOSPITAL SAMUNDARI

PART 1

PART 2

PART 3


PART 4

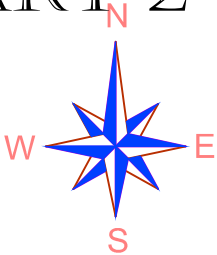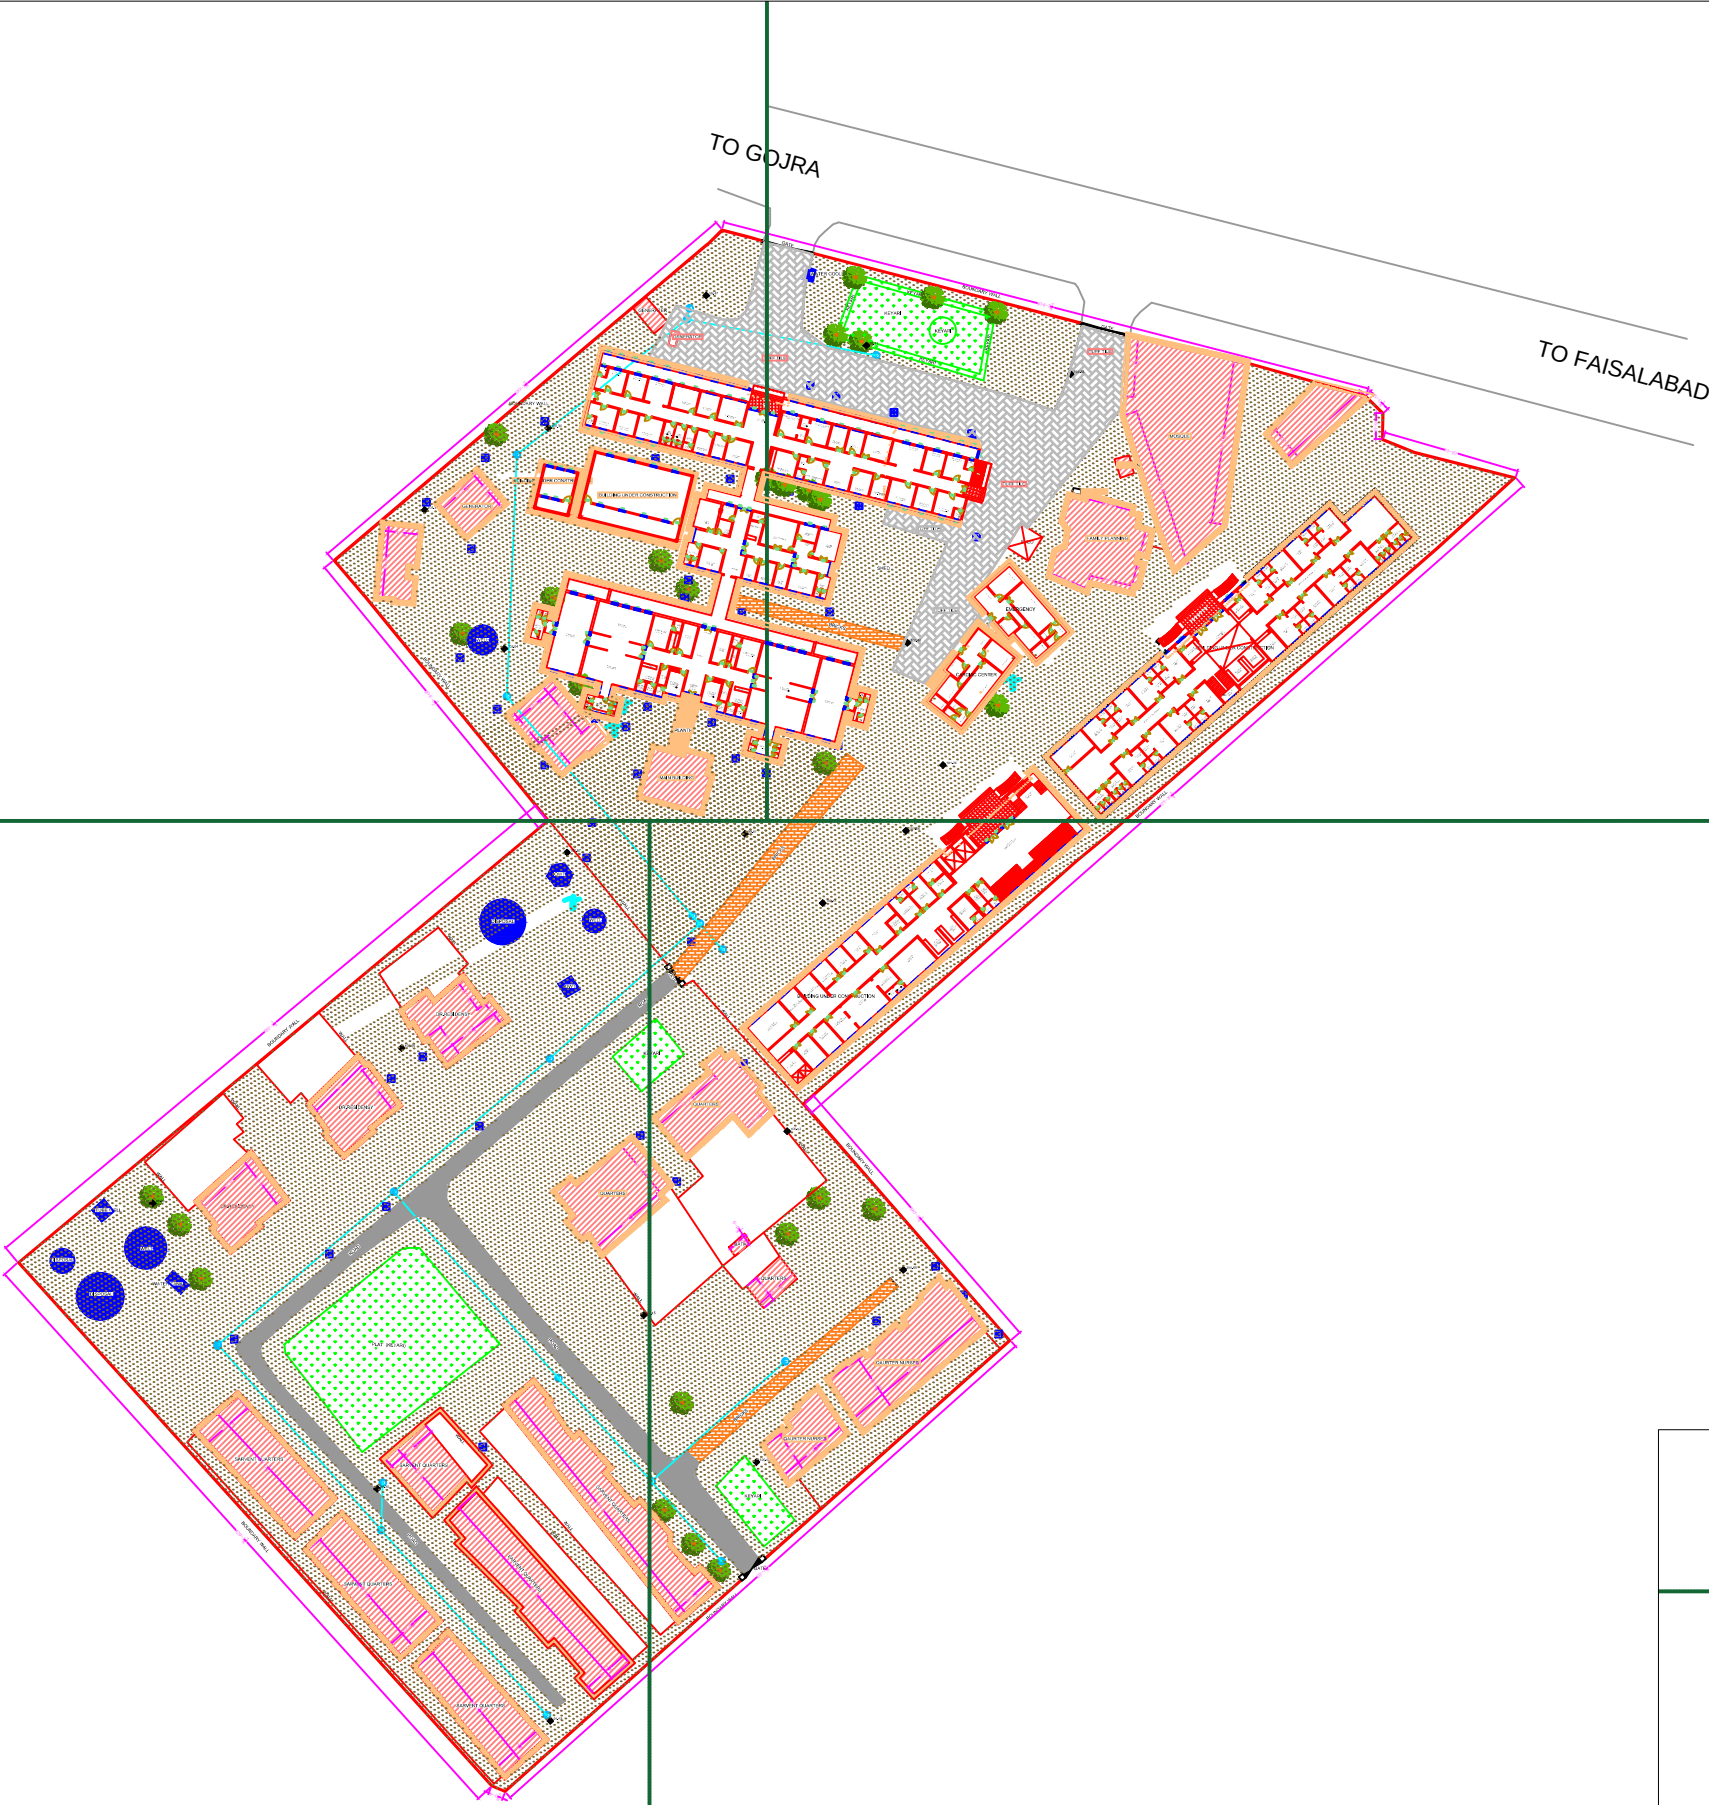

LEGENDS:	
RESIDENTIAL AREA	
ROAD	
WALL	
POWER LINE	
OHT	
TREE	
MAN HOLE	
TUBE WELL	
LIGHT POLE	
LAWNS	
EARTHEN AREAS	
ASPHALTS ROADS	
TOUGH PAVERS	
P.C.C / PLINTH PROTECTION	
BOUNDARY WALL	
BRICK PAVERS / SOLING	
DRAIN	
TAP	
HAND PUMP	
AIR CONDITIONER	
TUBE LIGHT	
FAN	
ROOF LIGHT	
BULB	

AREA	
AREA WITHIN BOUNDARY WALL	377148.13 SFT
AREA OF CLINICAL BLOCK	48029.72 SFT
PLINTH AREA OF BLOCK	6671.22 SFT

OPENING SCHEDULE OF DOORS AND WINDOWS					
DOORS	WIDTH	HEIGHT	WINDOWS	WIDTH	HEIGHT
D1	5'-0"	7'-0"	W1	3'-0"	5'-0"
D2	4'-0"	7'-0"	W2	3'-6"	5'-0"
D3	3'-6"	7'-0"	W3	6'-0"	5'-0"
D4	3'-0"	7'-0"	W4	4'-6"	5'-0"
D5	2'-6"	7'-0"	W5	8'-6"	5'-0"
D6	6'-0"	7'-0"	W6	7'-0"	5'-0"
VENTS	WIDTH	HEIGHT	W7	2'-6"	5'-0"
V1	1'-6"	2'-0"	W8	4'-0"	5'-0"
V2	2'-0"	2'-0"	W9	5'-0"	5'-0"
V3	3'-0"	2'-0"	W0	2'-0"	5'-0"

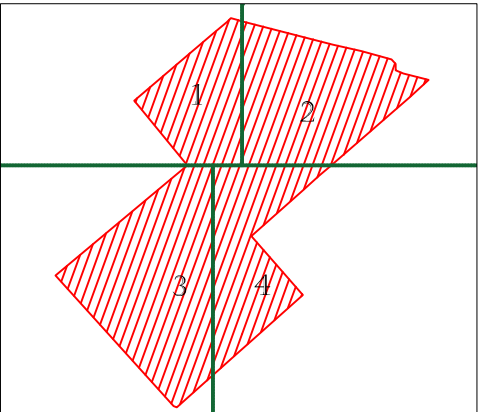

Project:

CAD MAPPING OF TEHSIL HEAD QUARTER HOSPITALS, PUNJAB

Client:

GOVERNMENT OF THE PUNJAB
PRIMARY & SECONDARY
HEALTHCARE DEPARTMENT

Consultant:

SKAFS CONSULTANT (Pvt.) Limited
ENGINEERING AND ENVIRONMENT
CONSULTANT

Drawing Title:



THQ SAMUNDARI HOSPITAL MASTER PLAN

Drawing No.

SKAFS/SAMUNDARI/03

MASTER PLAN OF THQ HOSPITAL SAMUNDARI

PART 1

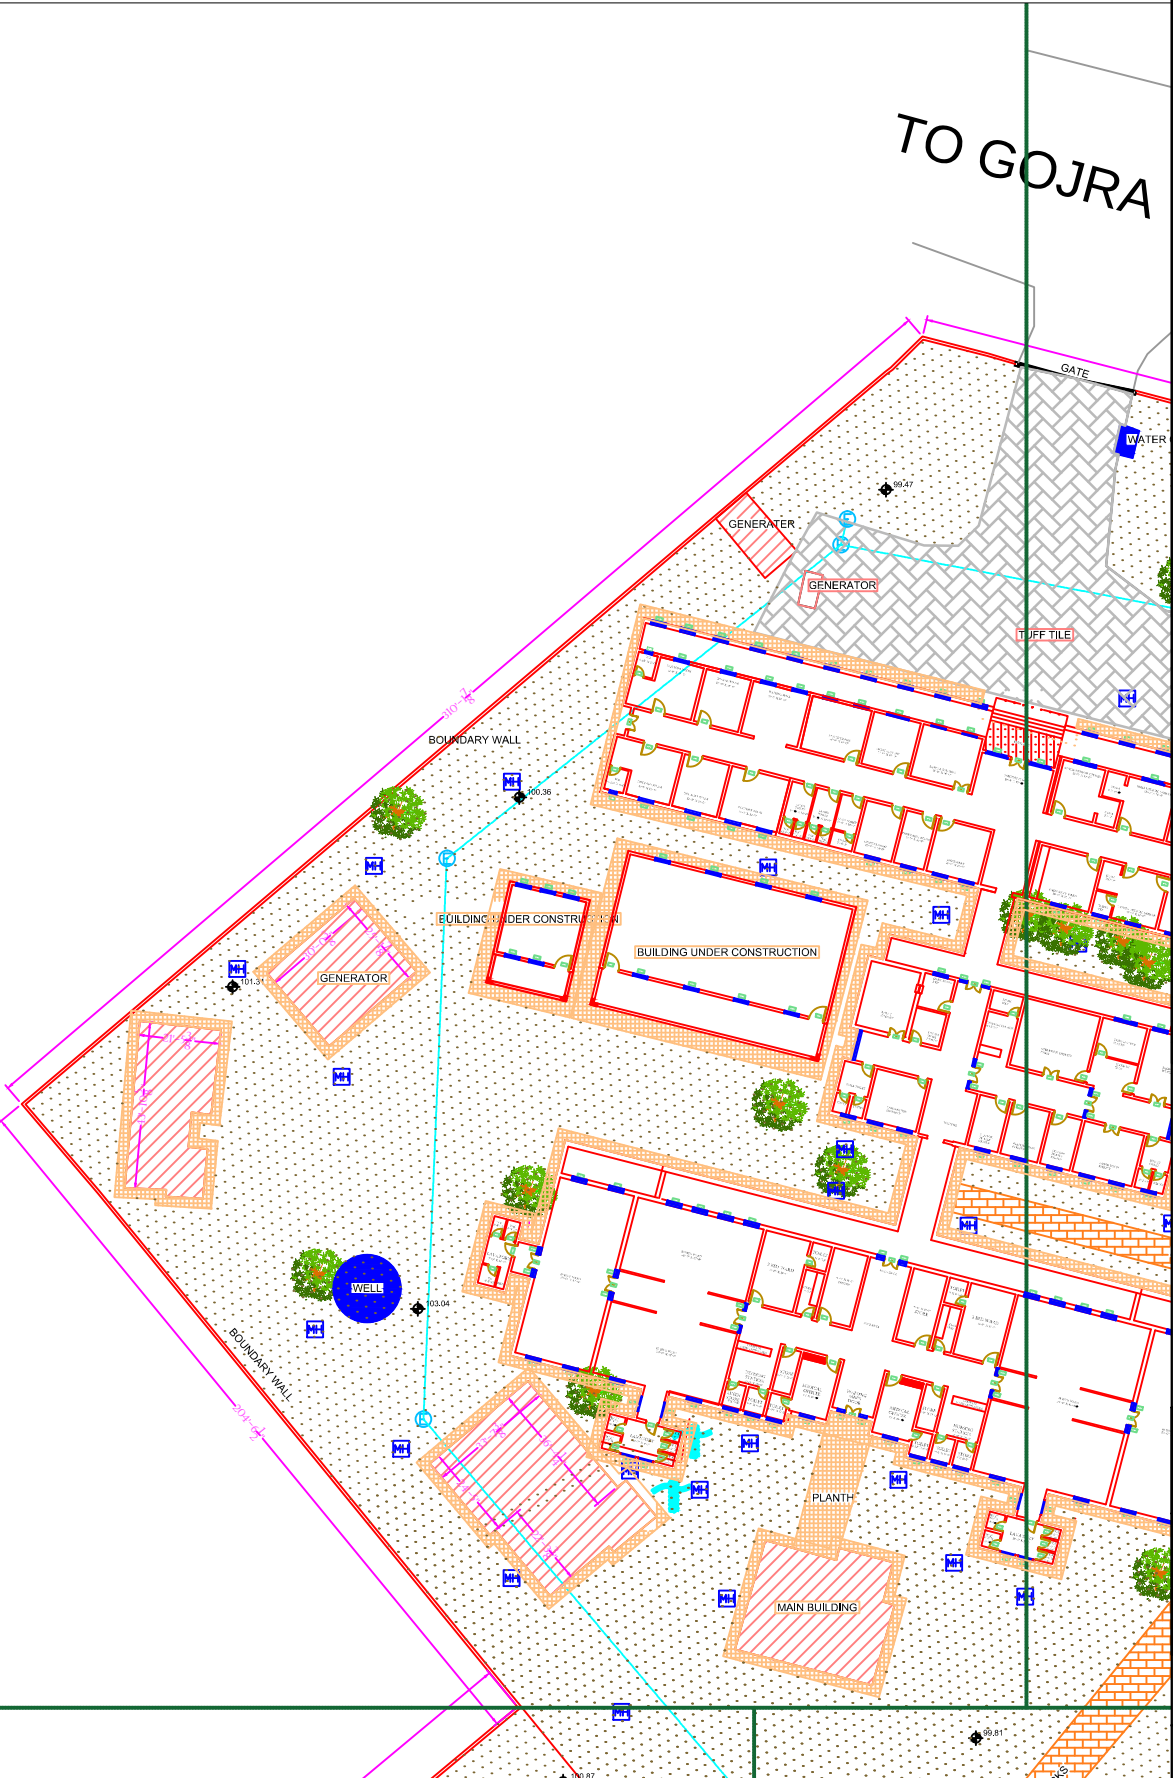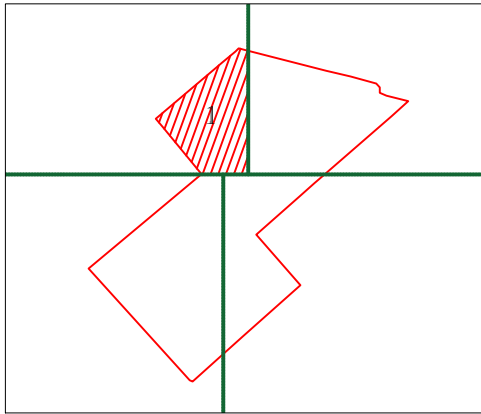

LEGENDS:	
RESIDENTIAL AREA	
ROAD	
WALL	
POWER LINE	
OHT	
TREE	
MAN HOLE	
TUBE WELL	
LIGHT POLE	
LAWNS	
EARTHEN AREAS	
ASPHALTS ROADS	
TOUGH PAVERS	
P.C.C / PLINTH PROTECTION	
BOUNDARY WALL	
BRICK PAVERS / SOLING	
DRAIN	
TAP	
HAND PUMP	
AIR CONDITIONER	
TUBE LIGHT	
FAN	
ROOF LIGHT	
BULB	

AREA	
AREA WITHIN BOUNDARY WALL	377148.13 SFT
AREA OF CLINICAL BLOCK	48029.72 SFT
PLINTH AREA OF BLOCK	6671.22 SFT

OPENING SCHEDULE OF DOORS AND WINDOWS					
DOORS	WIDTH	HEIGHT	WINDOWS	WIDTH	HEIGHT
D1	5'-0"	7'-0"	W1	3'-0"	5'-0"
D2	4'-0"	7'-0"	W2	3'-6"	5'-0"
D3	3'-6"	7'-0"	W3	6'-0"	5'-0"
D4	3'-0"	7'-0"	W4	4'-6"	5'-0"
D5	2'-6"	7'-0"	W5	8'-6"	5'-0"
D6	6'-0"	7'-0"	W6	7'-0"	5'-0"
VENTS	WIDTH	HEIGHT	W7	2'-6"	5'-0"
V1	1'-6"	2'-0"	W8	4'-0"	5'-0"
V2	2'-0"	2'-0"	W9	5'-0"	5'-0"
V3	3'-0"	2'-0"	W0	2'-0"	5'-0"

Project:
**CAD MAPPING OF TEHSIL
HEAD QUARTER HOSPITALS,
PUNJAB**

Client: GOVERNMENT OF THE PUNJAB PRIMARY & SECONDARY HEALTHCARE DEPARTMENT	Consultant: SKAFS CONSULTANT (Pvt.) Limited ENGINEERING AND ENVIRONMENT CONSULTANT
---	--

Drawing Title:
**THQ SAMUNDARI
HOSPITAL MASTER PLAN PART 1**

Drawing No.
SKAFS/SAMUNDARI/04

This detailed site plan illustrates the layout of a health facility in Gojra. The plan includes several key areas and structures:



- Keyari:** A large green rectangular area in the top left, labeled 'KEYARI', containing a 'WATER COOLER' and a 'GATE'.
- Mosque:** A large, hatched rectangular area in the center, labeled 'MOSQUE'.
- Family Planning:** A hatched area labeled 'FAMILY PLANNING'.
- Emergency:** A building labeled 'EMERGENCY'.
- Cardiac Center:** A building labeled 'CARDIAC CENTER'.
- Building Under Construction:** A large, hatched area labeled 'BUILDING UNDER CONSTRUCTION'.
- Other Structures:** Includes a 'SHED', 'BRICKS' area, and a 'GATE'.
- Infrastructure:** A 'BOUNDARY WALL' runs along the top and right sides. A road labeled 'TO FAISALABAD' is shown on the right. A 'GATE' is marked on the road.
- Map Details:** The plan includes various labels for buildings, areas, and infrastructure. It also shows a 'KEYARI' area with a 'WATER COOLER' and a 'GATE'. The plan is divided into sections by a 'BOUNDARY WALL' and a 'GATE'.

The plan is a detailed architectural drawing showing the layout of the facility, including buildings, roads, and other infrastructure. It is a technical drawing used for planning and construction purposes.

Drawing No. **SKAFS/SAMUNDARI/05**

MASTER PLAN OF THQ HOSPITAL SAMUNDARI

PART 3

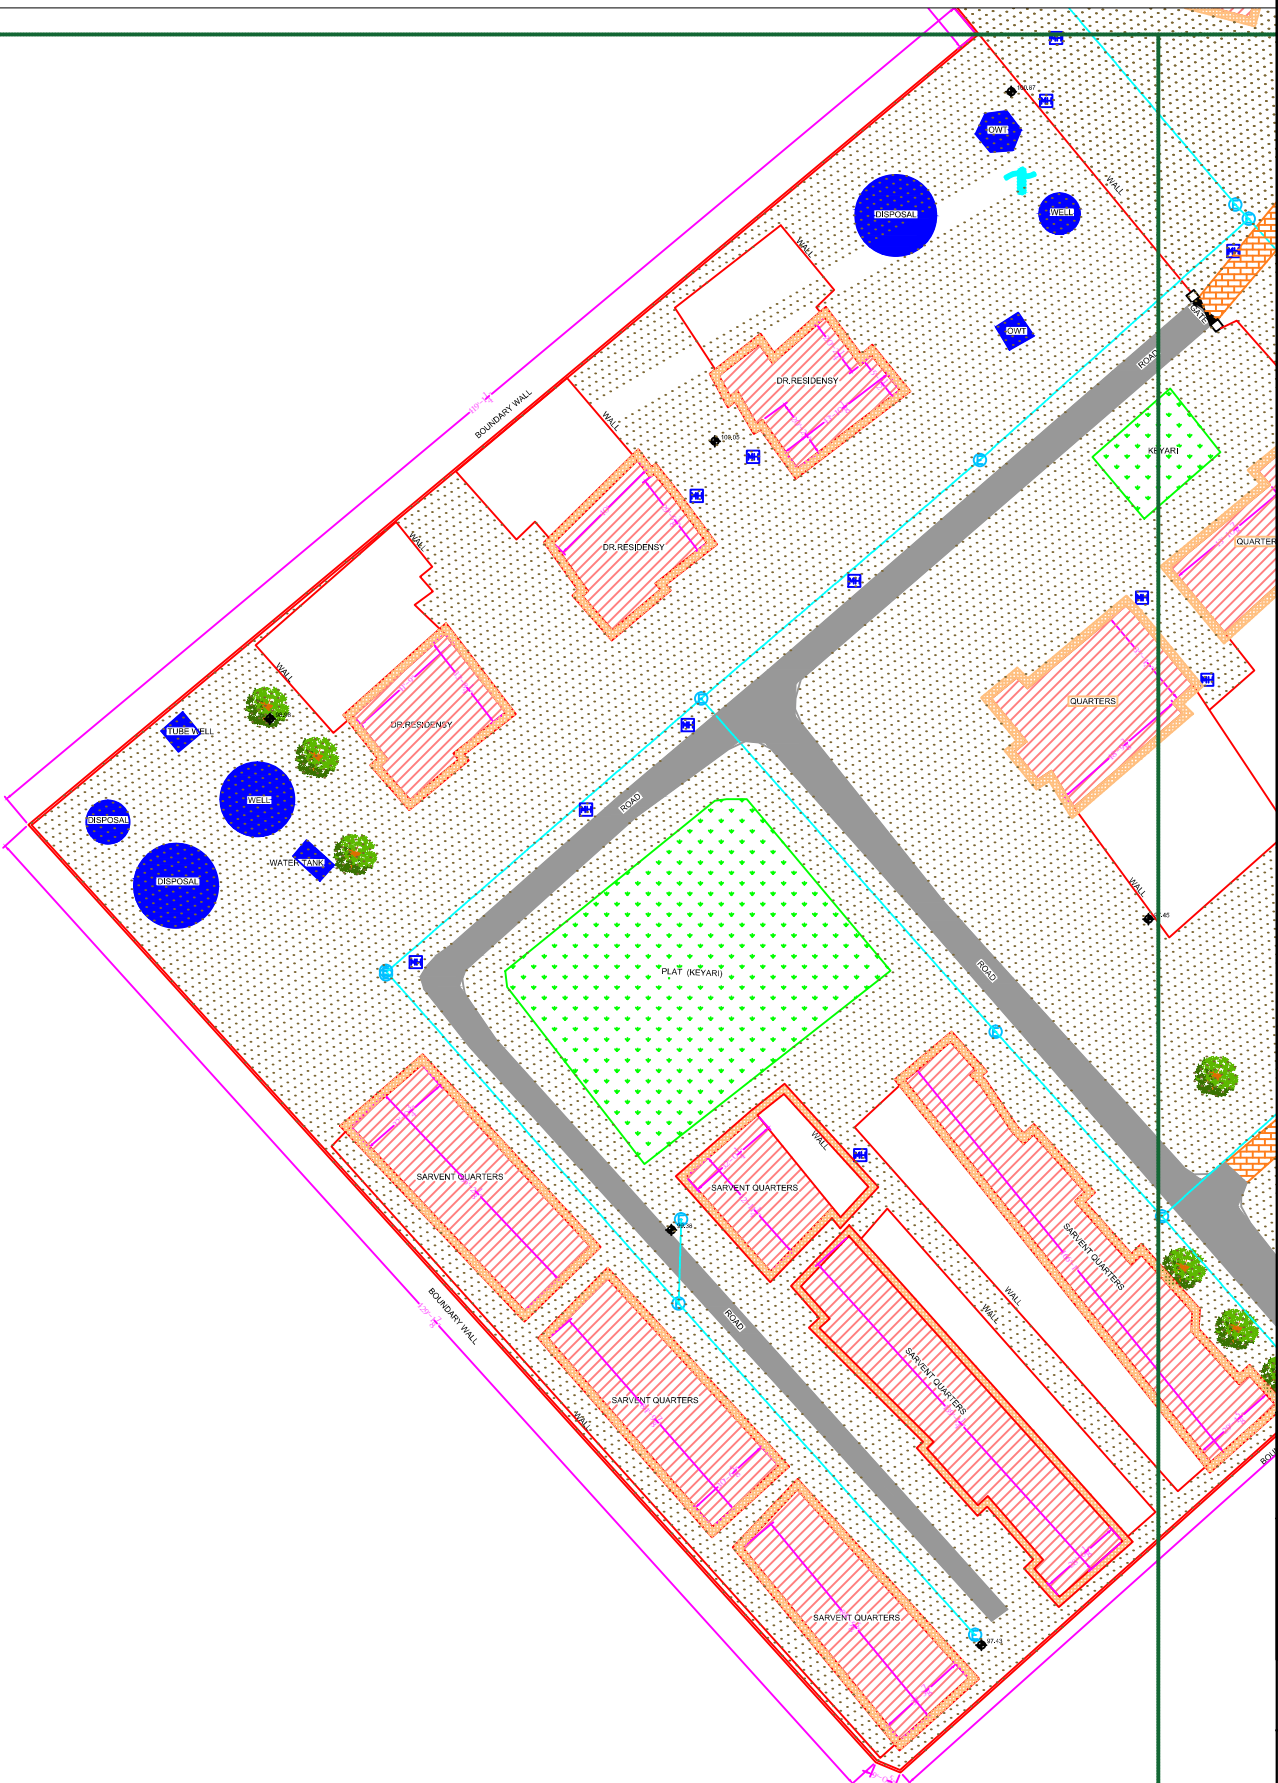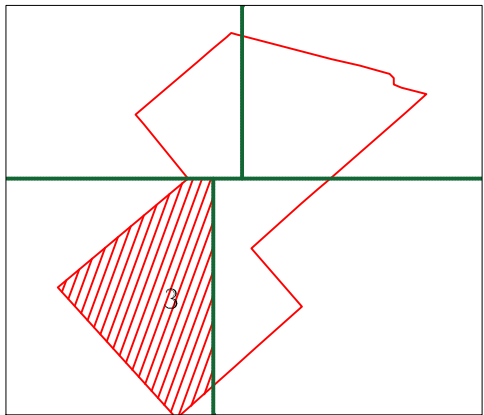

LEGENDS:	
RESIDENTIAL AREA	
ROAD	
WALL	
POWER LINE	
OHT	
TREE	
MAN HOLE	
TUBE WELL	
LIGHT POLE	
LAWNS	
EARTHEN AREAS	
ASPHALTS ROADS	
TOUGH PAVERS	
P.C.C / PLINTH PROTECTION	
BOUNDARY WALL	
BRICK PAVERS / SOLING	
DRAIN	
TAP	
HAND PUMP	
AIR CONDITIONER	
TUBE LIGHT	
FAN	
ROOF LIGHT	
BULB	

AREA	
AREA WITHIN BOUNDARY WALL	377148.13 SFT
AREA OF CLINICAL BLOCK	48029.72 SFT
PLINTH AREA OF BLOCK	6671.22 SFT

OPENING SCHEDULE OF DOORS AND WINDOWS					
DOORS	WIDTH	HEIGHT	WINDOWS	WIDTH	HEIGHT
D1	5'-0"	7'-0"	W1	3'-0"	5'-0"
D2	4'-0"	7'-0"	W2	3'-6"	5'-0"
D3	3'-6"	7'-0"	W3	6'-0"	5'-0"
D4	3'-0"	7'-0"	W4	4'-6"	5'-0"
D5	2'-6"	7'-0"	W5	8'-6"	5'-0"
D6	6'-0"	7'-0"	W6	7'-0"	5'-0"
VENTS	WIDTH	HEIGHT	W7	2'-6"	5'-0"
V1	1'-6"	2'-0"	W8	4'-0"	5'-0"
V2	2'-0"	2'-0"	W9	5'-0"	5'-0"
V3	3'-0"	2'-0"	W0	2'-0"	5'-0"

Project:
**CAD MAPPING OF TEHSIL
HEAD QUARTER HOSPITALS,
PUNJAB**


Client: GOVERNMENT OF THE PUNJAB PRIMARY & SECONDARY HEALTHCARE DEPARTMENT	Consultant: SKAFS CONSULTANT (Pvt.) Limited ENGINEERING AND ENVIRONMENT CONSULTANT
---	--

Drawing Title:
**THQ SAMUNDARI
HOSPITAL MASTER PLAN PART 3**

Drawing No.
SKAFS/SAMUNDARI/06

MASTER PLAN OF THQ HOSPITAL SAMUNDARI

PART 4

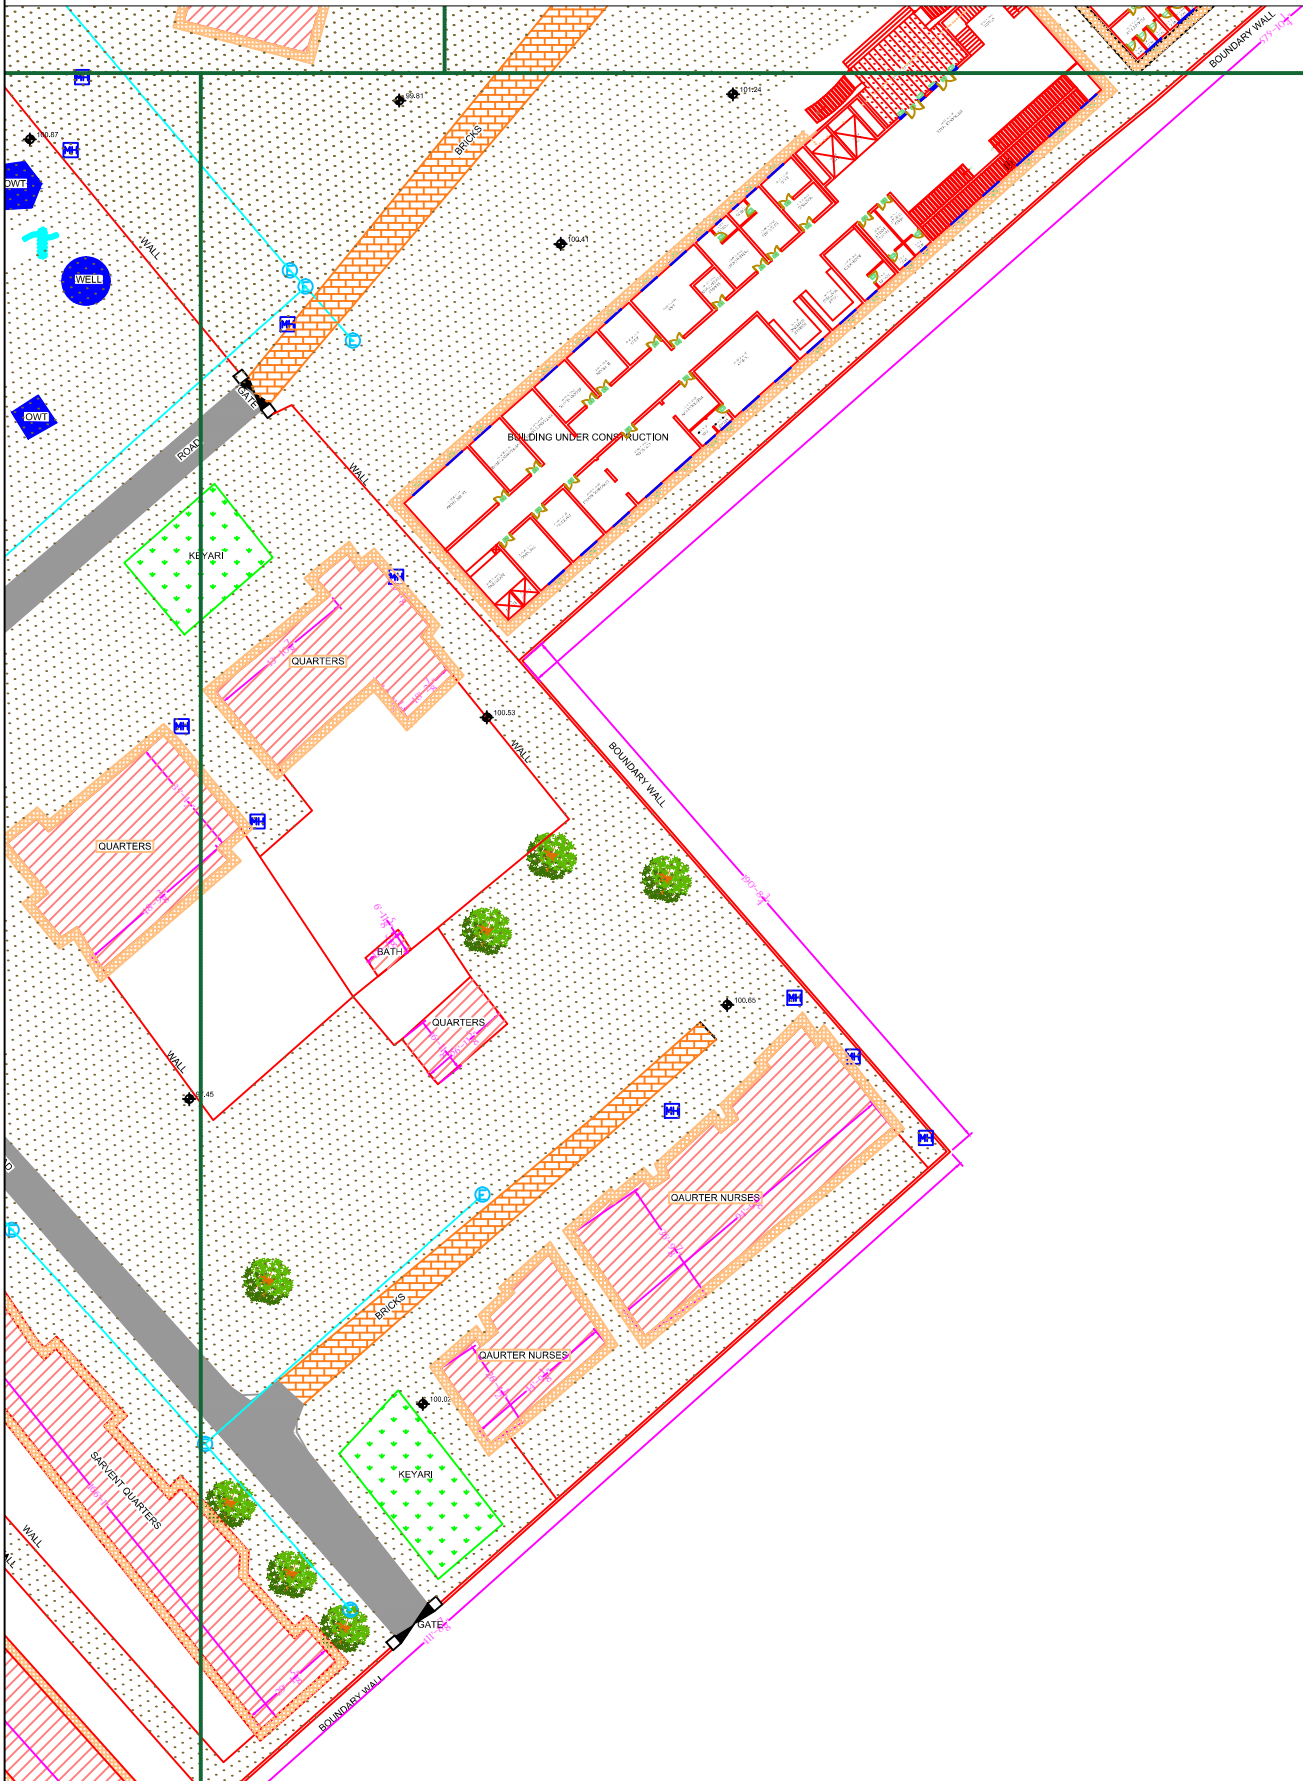

LEGENDS:

RESIDENTIAL AREA	
ROAD	
WALL	
POWER LINE	
OHT	
TREE	
MAN HOLE	
TUBE WELL	
LIGHT POLE	
LAWNS	
EARTHEN AREAS	
ASPHALTS ROADS	
TOUGH PAVERS	
P.C.C / PLINTH PROTECTION	
BOUNDARY WALL	
BRICK PAVERS / SOLING	
DRAIN	
TAP	
HAND PUMP	
AIR CONDITIONER	
TUBE LIGHT	
FAN	
ROOF LIGHT	
BULB	

AREA	
AREA WITHIN BOUNDARY WALL	377148.13 SFT
AREA OF CLINICAL BLOCK	48029.72 SFT
PLINTH AREA OF BLOCK	6671.22 SFT


OPENING SCHEDULE OF DOORS AND WINDOWS					
DOORS	WIDTH	HEIGHT	WINDOWS	WIDTH	HEIGHT
D1	5'-0"	7'-0"	W1	3'-0"	5'-0"
D2	4'-0"	7'-0"	W2	3'-6"	5'-0"
D3	3'-6"	7'-0"	W3	6'-0"	5'-0"
D4	3'-0"	7'-0"	W4	4'-6"	5'-0"
D5	2'-6"	7'-0"	W5	8'-6"	5'-0"
D6	6'-0"	7'-0"	W6	7'-0"	5'-0"
VENTS	WIDTH	HEIGHT	W7	2'-6"	5'-0"
V1	1'-6"	2'-0"	W8	4'-0"	5'-0"
V2	2'-0"	2'-0"	W9	5'-0"	5'-0"
V3	3'-0"	2'-0"	W0	2'-0"	5'-0"

Project:
**CAD MAPPING OF TEHSIL
HEAD QUARTER HOSPITALS,
PUNJAB**

Client: GOVERNMENT OF THE PUNJAB PRIMARY & SECONDARY HEALTHCARE DEPARTMENT	Consultant: SKAFS CONSULTANT (Pvt.) Limited ENGINEERING AND ENVIRONMENT CONSULTANT
---	--

Drawing Title:
**THQ SAMUNDARI
HOSPITAL MASTER PLAN PART 4**

Drawing No.
SKAFS/SAMUNDARI/07

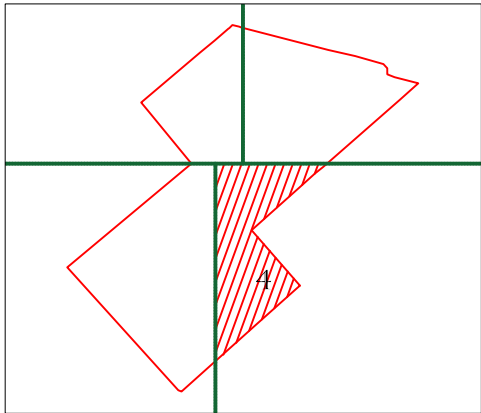

CLINICAL BLOCK OF THQ HOSPITAL SAMUNDARI

GROUND FLOOR

PART 1

PART 2

PART 3

PART 4

LEGENDS:

RESIDENTIAL AREA	
ROAD	
WALL	
POWER LINE	
OHT	
TREE	
MAN HOLE	
TUBE WELL	
LIGHT POLE	
LAWNS	
EARTHEN AREAS	
ASPHALTS ROADS	
TOUGH PAVERS	
P.C.C / PLINTH PROTECTION	
BOUNDARY WALL	
BRICK PAVERS / SOLING	
DRAIN	
TAP	
HAND PUMP	
AIR CONDITIONER	
TUBE LIGHT	
FAN	
ROOF LIGHT	
BULB	

AREA					
AREA WITHIN BOUNDARY WALL			377148.13 SFT		
AREA OF CLINICAL BLOCK			48029.72 SFT		
PLINTH AREA OF BLOCK			6671.22 SFT		

OPENING SCHEDULE OF DOORS AND WINDOWS					
DOORS	WIDTH	HEIGHT	WINDOWS	WIDTH	HEIGHT
D1	5'-0"	7'-0"	W1	3'-0"	5'-0"
D2	4'-0"	7'-0"	W2	3'-6"	5'-0"
D3	3'-6"	7'-0"	W3	6'-0"	5'-0"
D4	3'-0"	7'-0"	W4	4'-6"	5'-0"
D5	2'-6"	7'-0"	W5	8'-6"	5'-0"
D6	6'-0"	7'-0"	W6	7'-0"	5'-0"
VENTS	WIDTH	HEIGHT	W7	2'-6"	5'-0"
V1	1'-6"	2'-0"	W8	4'-0"	5'-0"
V2	2'-0"	2'-0"	W9	5'-0"	5'-0"
V3	3'-0"	2'-0"	W0	2'-0"	5'-0"

Project:

**CAD MAPPING OF TEHSIL
HEAD QUARTER HOSPITALS,
PUNJAB**

Client:



GOVERNMENT OF THE PUNJAB
PRIMARY & SECONDARY
HEALTHCARE DEPARTMENT

Consultant:



SKAFS CONSULTANT (Pvt.)
Limited
ENGINEERING AND ENVIRONMENT
CONSULTANT

Drawing Title:


**THQ SAMUNDARI
HOSPITAL CLINICAL BLOCK PLAN**

Drawing No.

SKAFS/SAMUNDARI/08

CLINICAL BLOCK OF THQ HOSPITAL SAMUNDARI

GROUND FLOOR PART 1

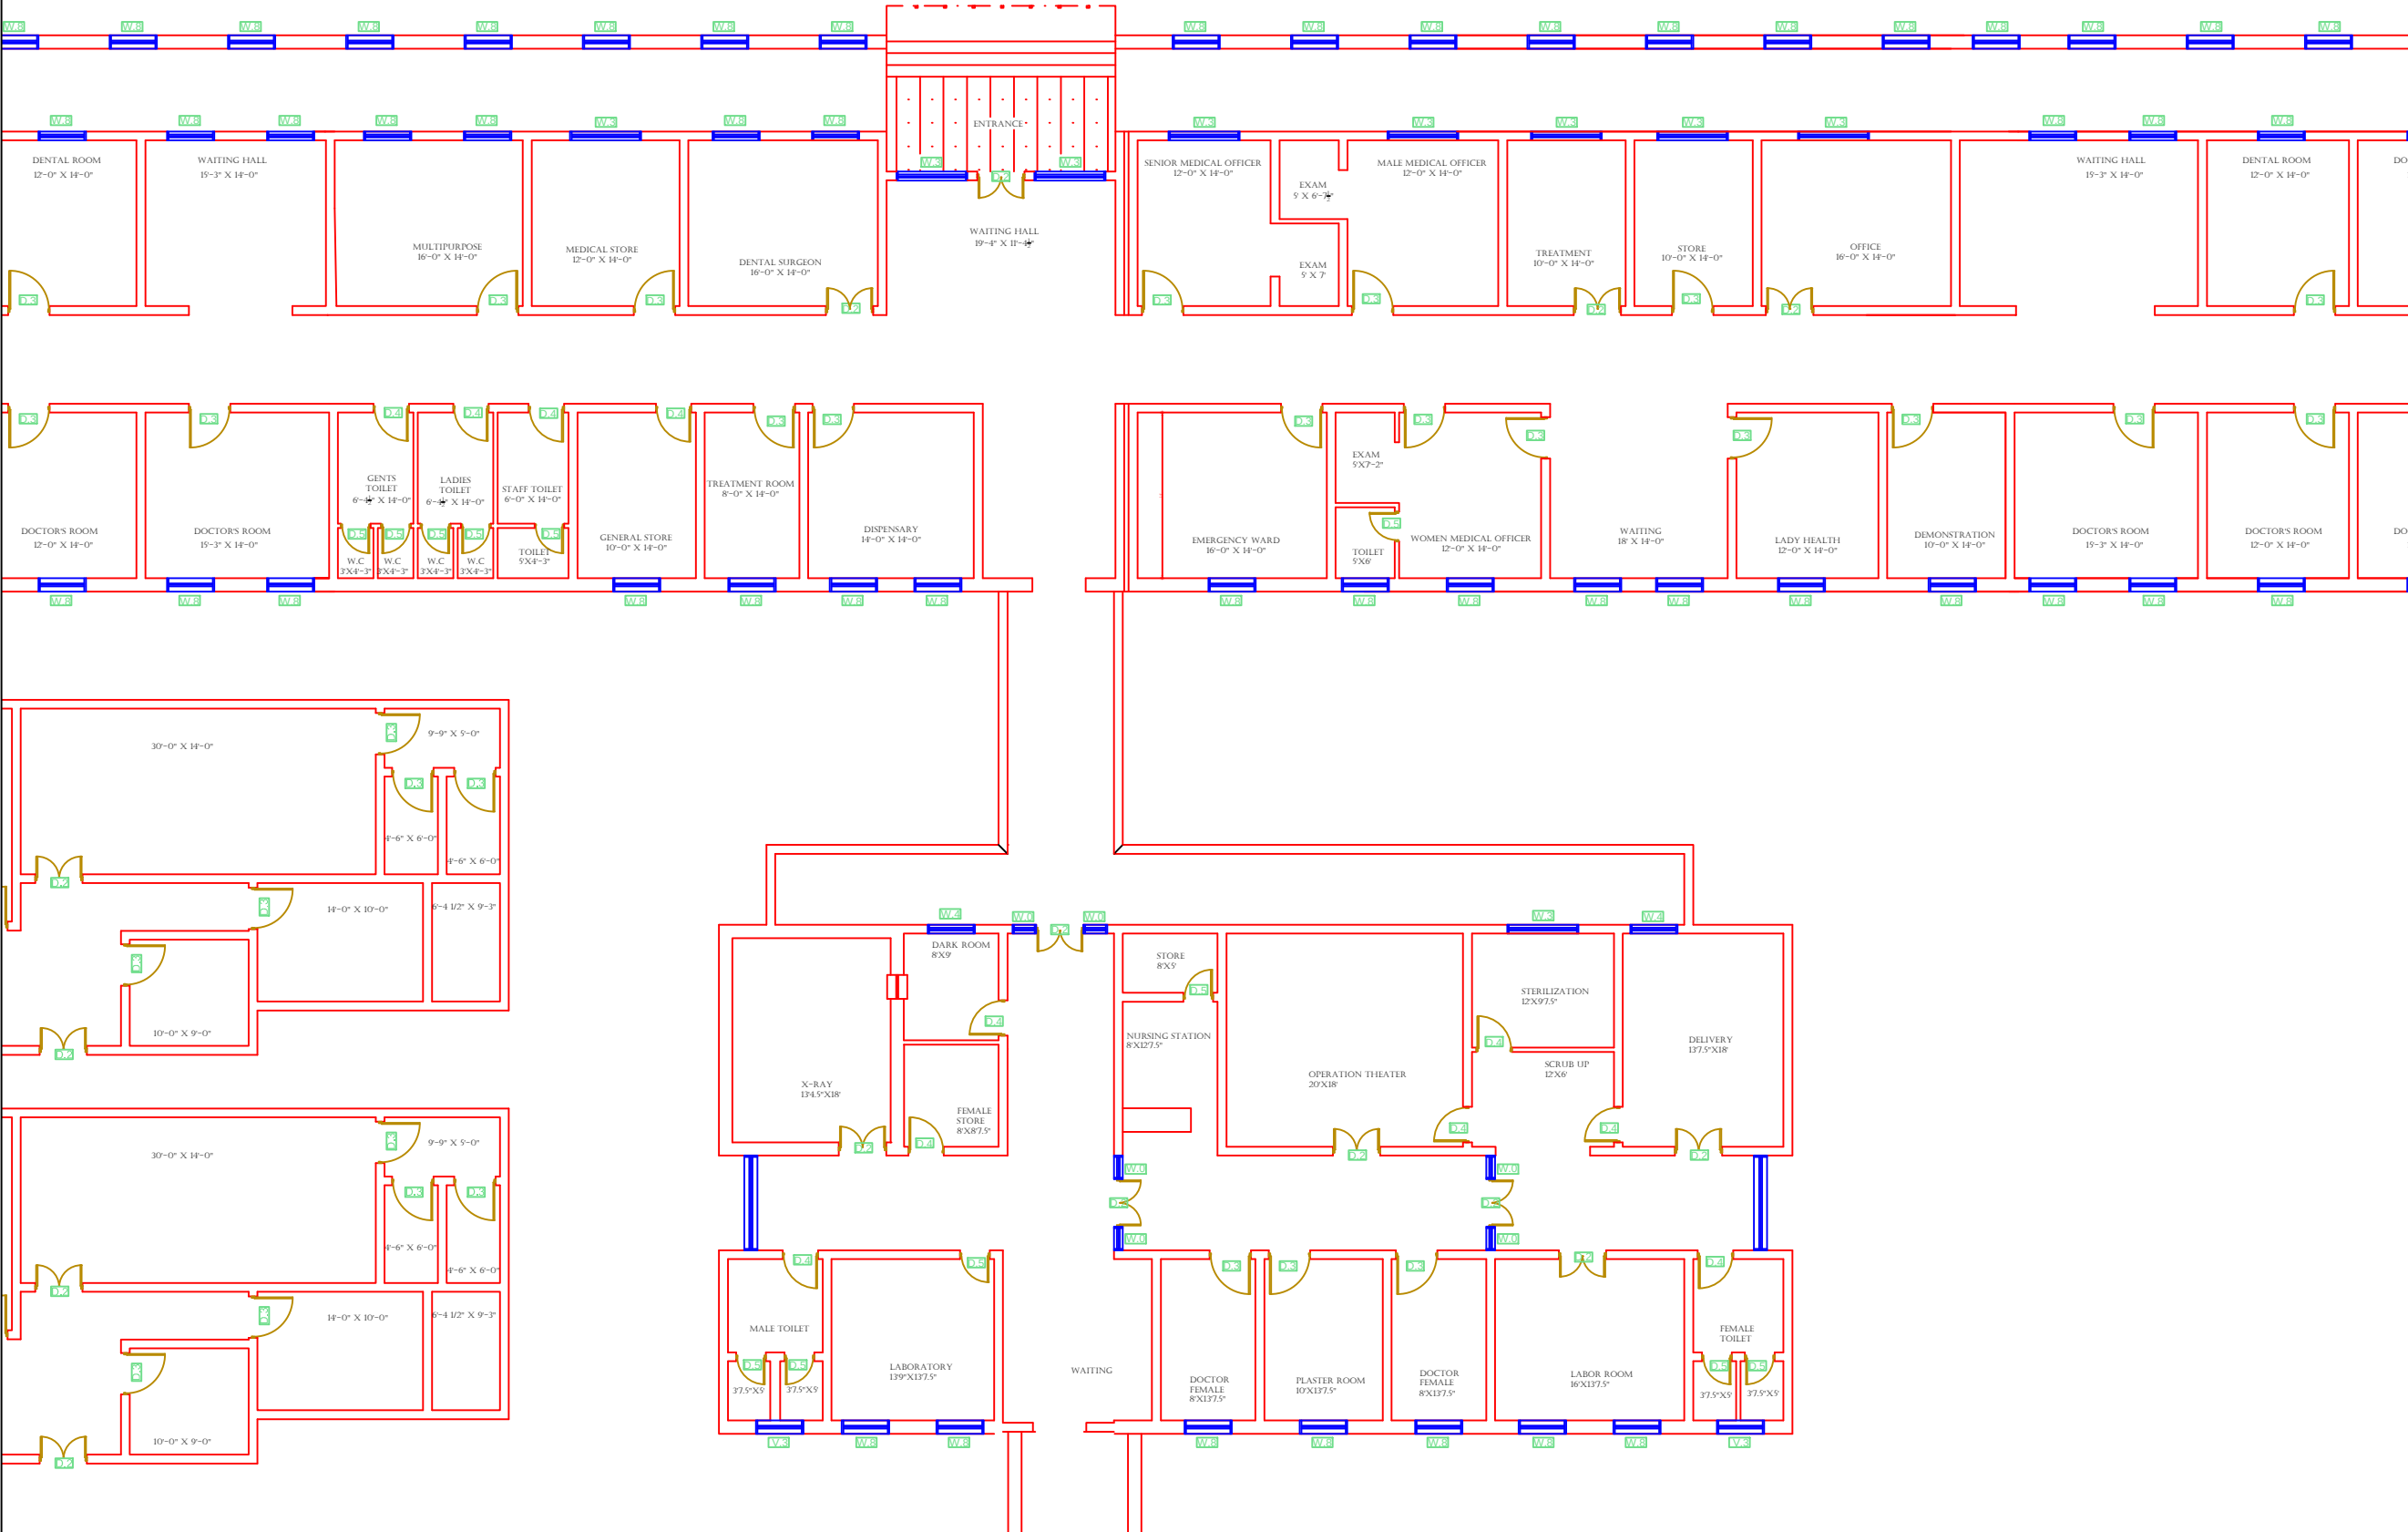

LEGENDS:

RESIDENTIAL AREA	
ROAD	
WALL	
POWER LINE	
OHT	
TREE	
MAN HOLE	
TUBE WELL	
LIGHT POLE	
LAWNS	
EARTHEN AREAS	
ASPHALTS ROADS	
TOUGH PAVERS	
P.C.C / PLINTH PROTECTION	
BOUNDARY WALL	
BRICK PAVERS / SOLING	
DRAIN	
TAP	
HAND PUMP	
AIR CONDITIONER	
TUBE LIGHT	
FAN	
ROOF LIGHT	
BULB	

AREA	
AREA WITHIN BOUNDARY WALL	377148.13 SFT
AREA OF CLINICAL BLOCK	48029.72 SFT
PLINTH AREA OF BLOCK	6671.22 SFT

OPENING SCHEDULE OF DOORS AND WINDOWS					
DOORS	WIDTH	HEIGHT	WINDOWS	WIDTH	HEIGHT
D1	5'-0"	7'-0"	W1	3'-0"	5'-0"
D2	4'-0"	7'-0"	W2	3'-6"	5'-0"
D3	3'-6"	7'-0"	W3	6'-0"	5'-0"
D4	3'-0"	7'-0"	W4	4'-6"	5'-0"
D5	2'-6"	7'-0"	W5	8'-6"	5'-0"
D6	6'-0"	7'-0"	W6	7'-0"	5'-0"
VENTS	WIDTH	HEIGHT	W7	2'-6"	5'-0"
V1	1'-6"	2'-0"	W8	4'-0"	5'-0"
V2	2'-0"	2'-0"	W9	5'-0"	5'-0"
V3	3'-0"	2'-0"	W0	2'-0"	5'-0"

Project:
**CAD MAPPING OF TEHSIL
HEAD QUARTER HOSPITALS,
PUNJAB**

Client:

GOVERNMENT OF THE PUNJAB
PRIMARY & SECONDARY
HEALTHCARE DEPARTMENT

Consultant:


SKAFS CONSULTANT (Pvt.)
Limited
ENGINEERING AND ENVIRONMENT
CONSULTANT

Drawing Title:
**THQ SAMUNDARI
CLINICAL BLOCK PLAN (PART 1)**

Drawing No.
SKAFS/SAMUNDARI/09

CLINICAL BLOCK OF THQ HOSPITAL SAMUNDARI

GROUND FLOOR PART 2

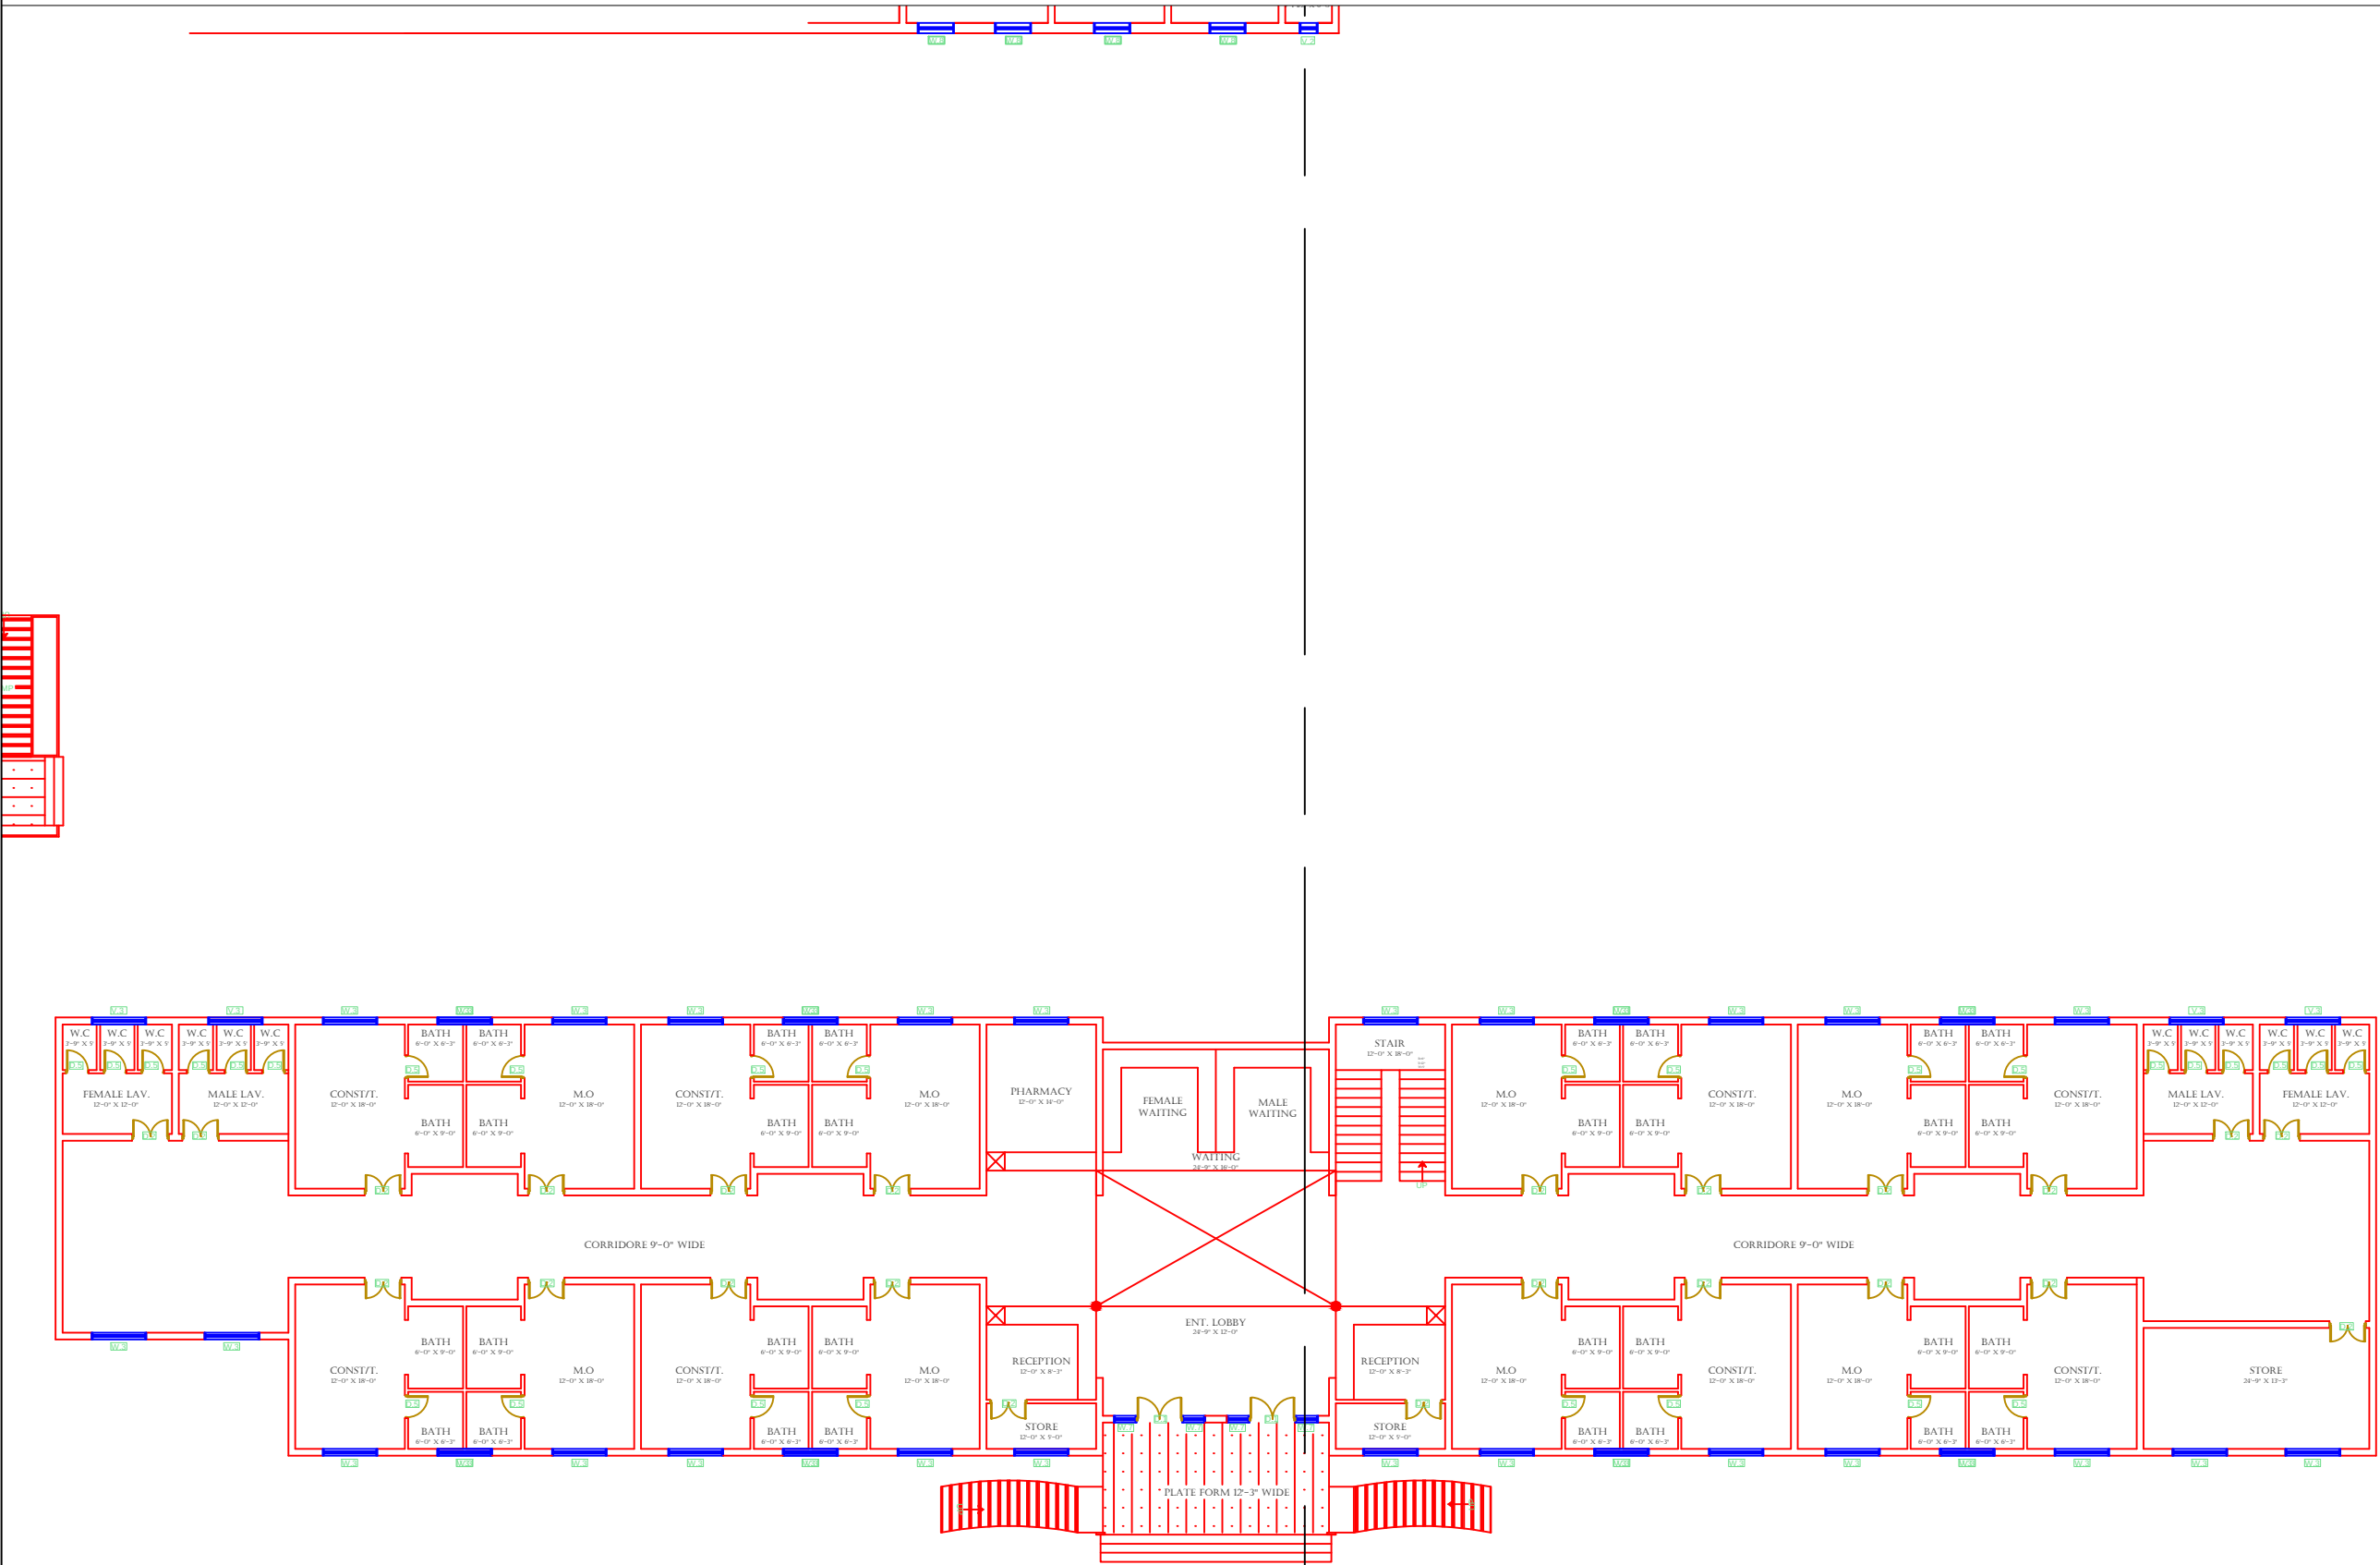

LEGENDS:

RESIDENTIAL AREA	
ROAD	
WALL	
POWER LINE	
OHT	
TREE	
MAN HOLE	
TUBE WELL	
LIGHT POLE	
LAWNS	
EARTHEN AREAS	
ASPHALTS ROADS	
TOUGH PAVERS	
P.C.C / PLINTH PROTECTION	
BOUNDARY WALL	
BRICK PAVERS / SOLING	
DRAIN	
TAP	
HAND PUMP	
AIR CONDITIONER	
TUBE LIGHT	
FAN	
ROOF LIGHT	
BULB	

AREA	
AREA WITHIN BOUNDARY WALL	377148.13 SFT
AREA OF CLINICAL BLOCK	48029.72 SFT
PLINTH AREA OF BLOCK	6671.22 SFT

OPENING SCHEDULE OF DOORS AND WINDOWS					
DOORS	WIDTH	HEIGHT	WINDOWS	WIDTH	HEIGHT
D1	5'-0"	7'-0"	W1	3'-0"	5'-0"
D2	4'-0"	7'-0"	W2	3'-6"	5'-0"
D3	3'-6"	7'-0"	W3	6'-0"	5'-0"
D4	3'-0"	7'-0"	W4	4'-6"	5'-0"
D5	2'-6"	7'-0"	W5	8'-6"	5'-0"
D6	6'-0"	7'-0"	W6	7'-0"	5'-0"
VENTS	WIDTH	HEIGHT	W7	2'-6"	5'-0"
V1	1'-6"	2'-0"	W8	4'-0"	5'-0"
V2	2'-0"	2'-0"	W9	5'-0"	5'-0"
V3	3'-0"	2'-0"	W0	2'-0"	5'-0"

Project: CAD MAPPING OF TEHSIL HEAD QUARTER HOSPITALS, PUNJAB


Client: GOVERNMENT OF THE PUNJAB PRIMARY & SECONDARY HEALTHCARE DEPARTMENT	Consultant: SKAFS CONSULTANT (Pvt.) Limited ENGINEERING AND ENVIRONMENT CONSULTANT
--	--

Drawing Title: THQ SAMUNDARI CLINICAL BLOCK PLAN (PART 2)

Drawing No. SKAFS/SAMUNDARI/10

CLINICAL BLOCK OF THQ HOSPITAL SAMUNDARI

GROUND FLOOR PART 3

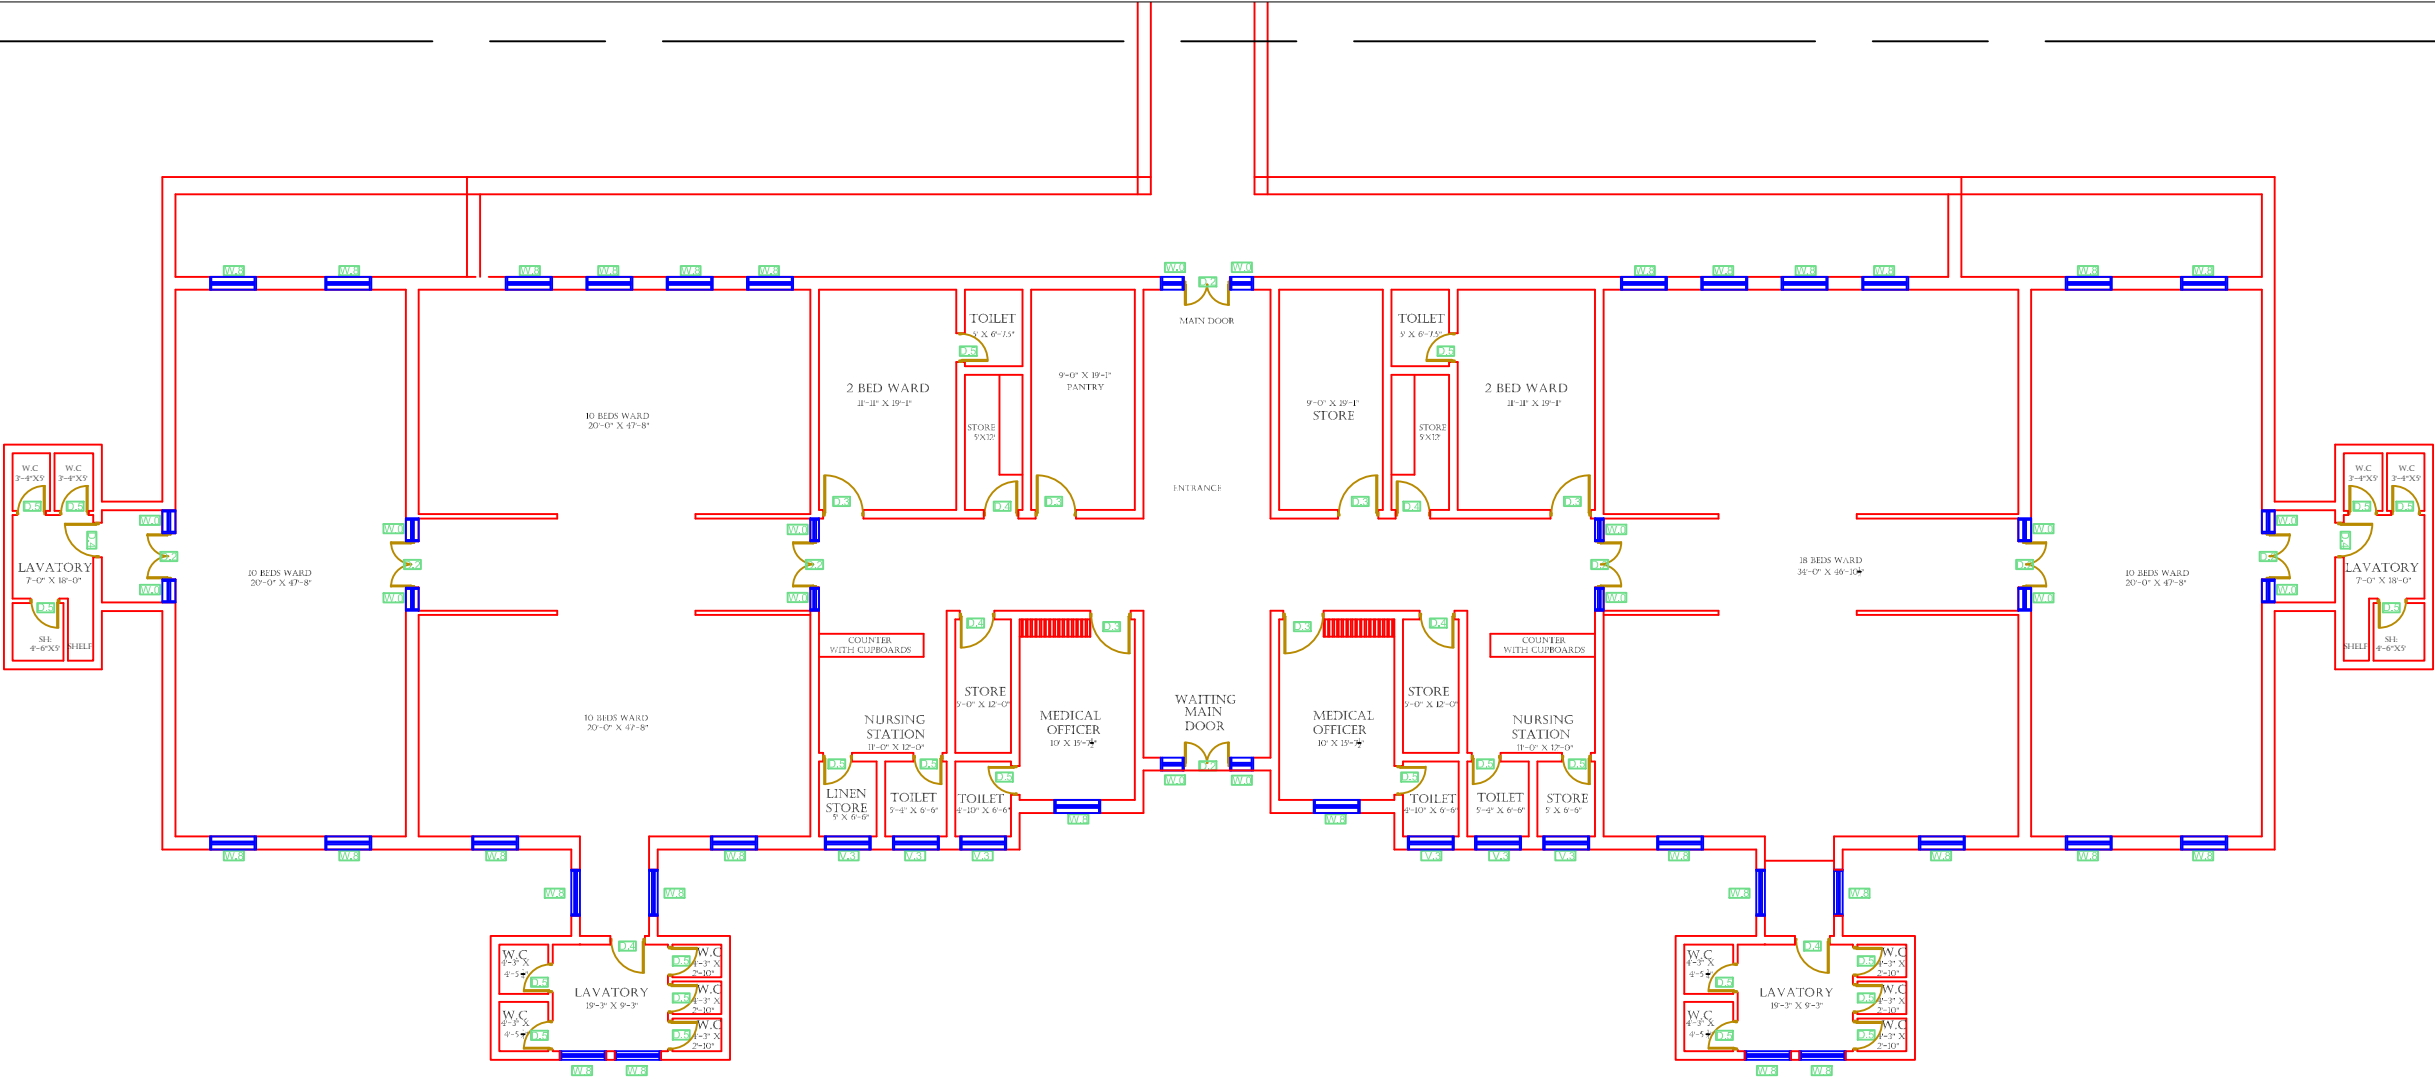

LEGENDS:	
RESIDENTIAL AREA	
ROAD	
WALL	
POWER LINE	
OHT	
TREE	
MAN HOLE	
TUBE WELL	
LIGHT POLE	
LAWNS	
EARTHEN AREAS	
ASPHALTS ROADS	
TOUGH PAVERS	
P.C.C / PLINTH PROTECTION	
BOUNDARY WALL	
BRICK PAVERS / SOLING	
DRAIN	
TAP	
HAND PUMP	
AIR CONDITIONER	
TUBE LIGHT	
FAN	
ROOF LIGHT	
BULB	

AREA	
AREA WITHIN BOUNDARY WALL	377148.13 SFT
AREA OF CLINICAL BLOCK	48029.72 SFT
PLINTH AREA OF BLOCK	6671.22 SFT

OPENING SCHEDULE OF DOORS AND WINDOWS					
DOORS	WIDTH	HEIGHT	WINDOWS	WIDTH	HEIGHT
D1	5'-0"	7'-0"	W1	3'-0"	5'-0"
D2	4'-0"	7'-0"	W2	3'-6"	5'-0"
D3	3'-6"	7'-0"	W3	6'-0"	5'-0"
D4	3'-0"	7'-0"	W4	4'-6"	5'-0"
D5	2'-6"	7'-0"	W5	8'-6"	5'-0"
D6	6'-0"	7'-0"	W6	7'-0"	5'-0"
VENTS	WIDTH	HEIGHT	W7	2'-6"	5'-0"
V1	1'-6"	2'-0"	W8	4'-0"	5'-0"
V2	2'-0"	2'-0"	W9	5'-0"	5'-0"
V3	3'-0"	2'-0"	W0	2'-0"	5'-0"

Project:
**CAD MAPPING OF TEHSIL
HEAD QUARTER HOSPITALS,
PUNJAB**


Client:	Consultant:
 GOVERNMENT OF THE PUNJAB PRIMARY & SECONDARY HEALTHCARE DEPARTMENT	 SKAFS CONSULTANT (Pvt.) Limited ENGINEERING AND ENVIRONMENT CONSULTANT

Drawing Title:
**THQ SAMUNDARI
CLINICAL BLOCK PLAN (PART 3)**

Drawing No.
SKAFS/SAMUNDARI/11

CLINICAL BLOCK OF THQ HOSPITAL SAMUNDARI

GROUND FLOOR PART 4

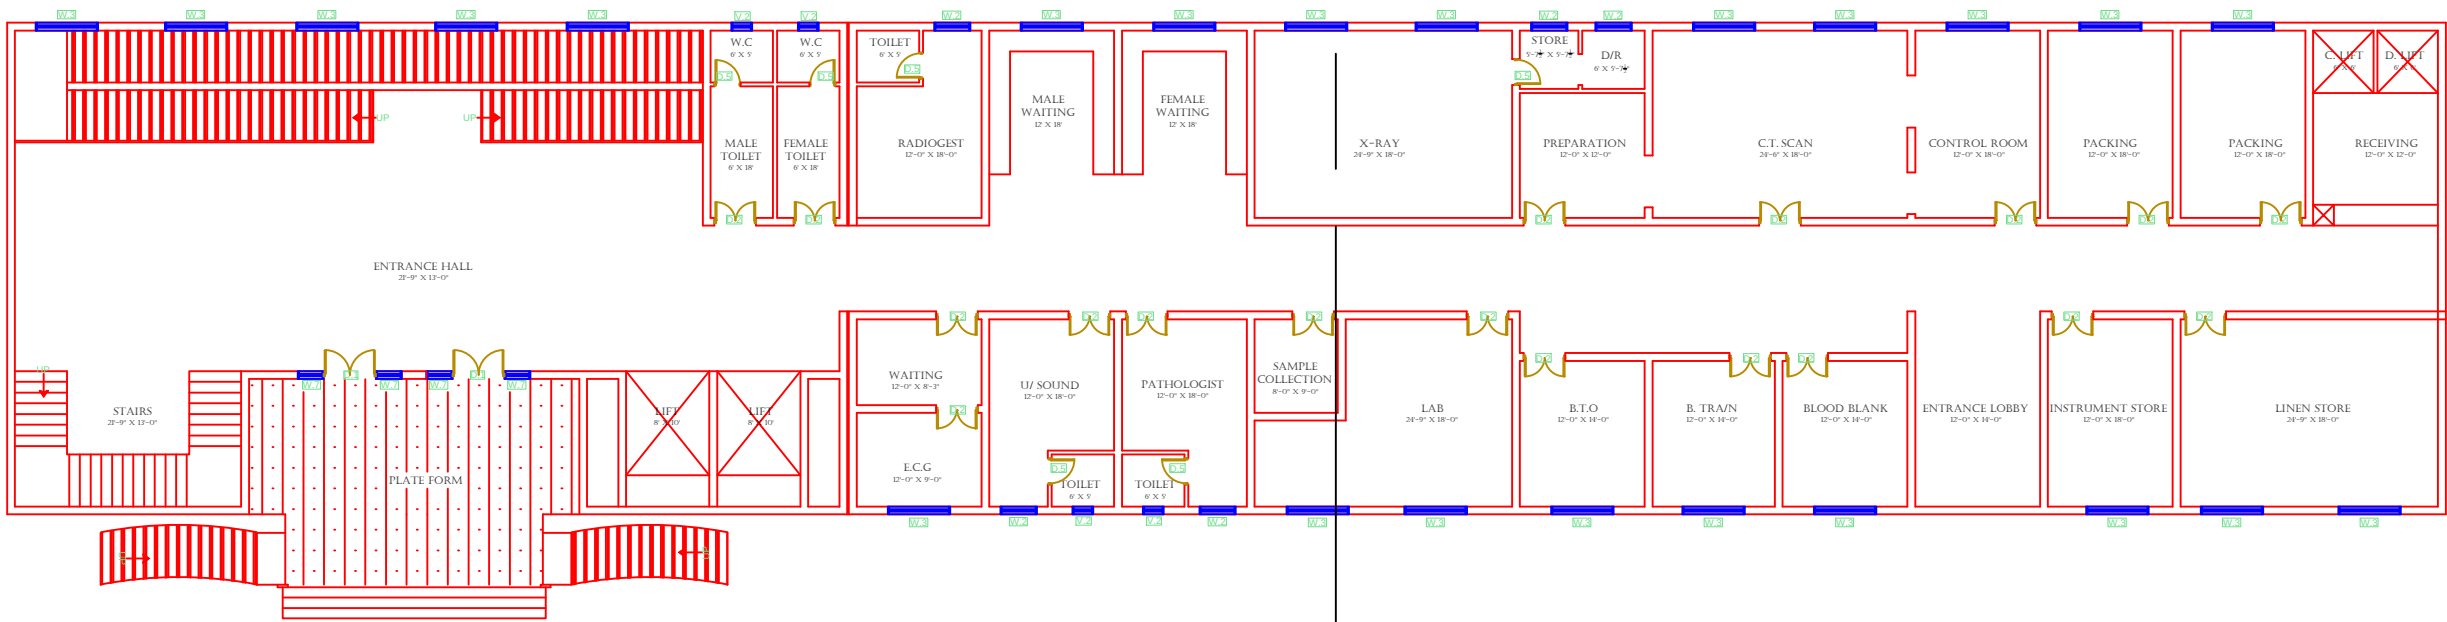

LEGENDS:

RESIDENTIAL AREA	
ROAD	
WALL	
POWER LINE	
OHT	
TREE	
MAN HOLE	
TUBE WELL	
LIGHT POLE	
LAWNS	
EARTHEN AREAS	
ASPHALTS ROADS	
TOUGH PAVERS	
P.C.C / PLINTH PROTECTION	
BOUNDARY WALL	
BRICK PAVERS / SOLING	
DRAIN	
TAP	
HAND PUMP	
AIR CONDITIONER	
TUBE LIGHT	
FAN	
ROOF LIGHT	
BULB	

AREA					
AREA WITHIN BOUNDARY WALL	377148.13 SFT				
AREA OF CLINICAL BLOCK	48029.72 SFT				
PLINTH AREA OF BLOCK	6671.22 SFT				

OPENING SCHEDULE OF DOORS AND WINDOWS					
DOORS	WIDTH	HEIGHT	WINDOWS	WIDTH	HEIGHT
D1	5'-0"	7'-0"	W1	3'-0"	5'-0"
D2	4'-0"	7'-0"	W2	3'-6"	5'-0"
D3	3'-6"	7'-0"	W3	6'-0"	5'-0"
D4	3'-0"	7'-0"	W4	4'-6"	5'-0"
D5	2'-6"	7'-0"	W5	8'-6"	5'-0"
D6	6'-0"	7'-0"	W6	7'-0"	5'-0"
VENTS	WIDTH	HEIGHT	W7	2'-6"	5'-0"
V1	1'-6"	2'-0"	W8	4'-0"	5'-0"
V2	2'-0"	2'-0"	W9	5'-0"	5'-0"
V3	3'-0"	2'-0"	W0	2'-0"	5'-0"

Project:

CAD MAPPING OF TEHSIL HEAD QUARTER HOSPITALS, PUNJAB


Client:	Consultant:
 GOVERNMENT OF THE PUNJAB PRIMARY & SECONDARY HEALTHCARE DEPARTMENT	 SKAFS CONSULTANT (Pvt.) Limited ENGINEERING AND ENVIRONMENT CONSULTANT

Drawing Title: **THQ SAMUNDARI CLINICAL BLOCK PLAN (PART 4)**

Drawing No. **SKAFS/SAMUNDARI/12**

CLINICAL BLOCK OF THQ HOSPITAL SAMUNDARI

FIRST FLOOR PART 1

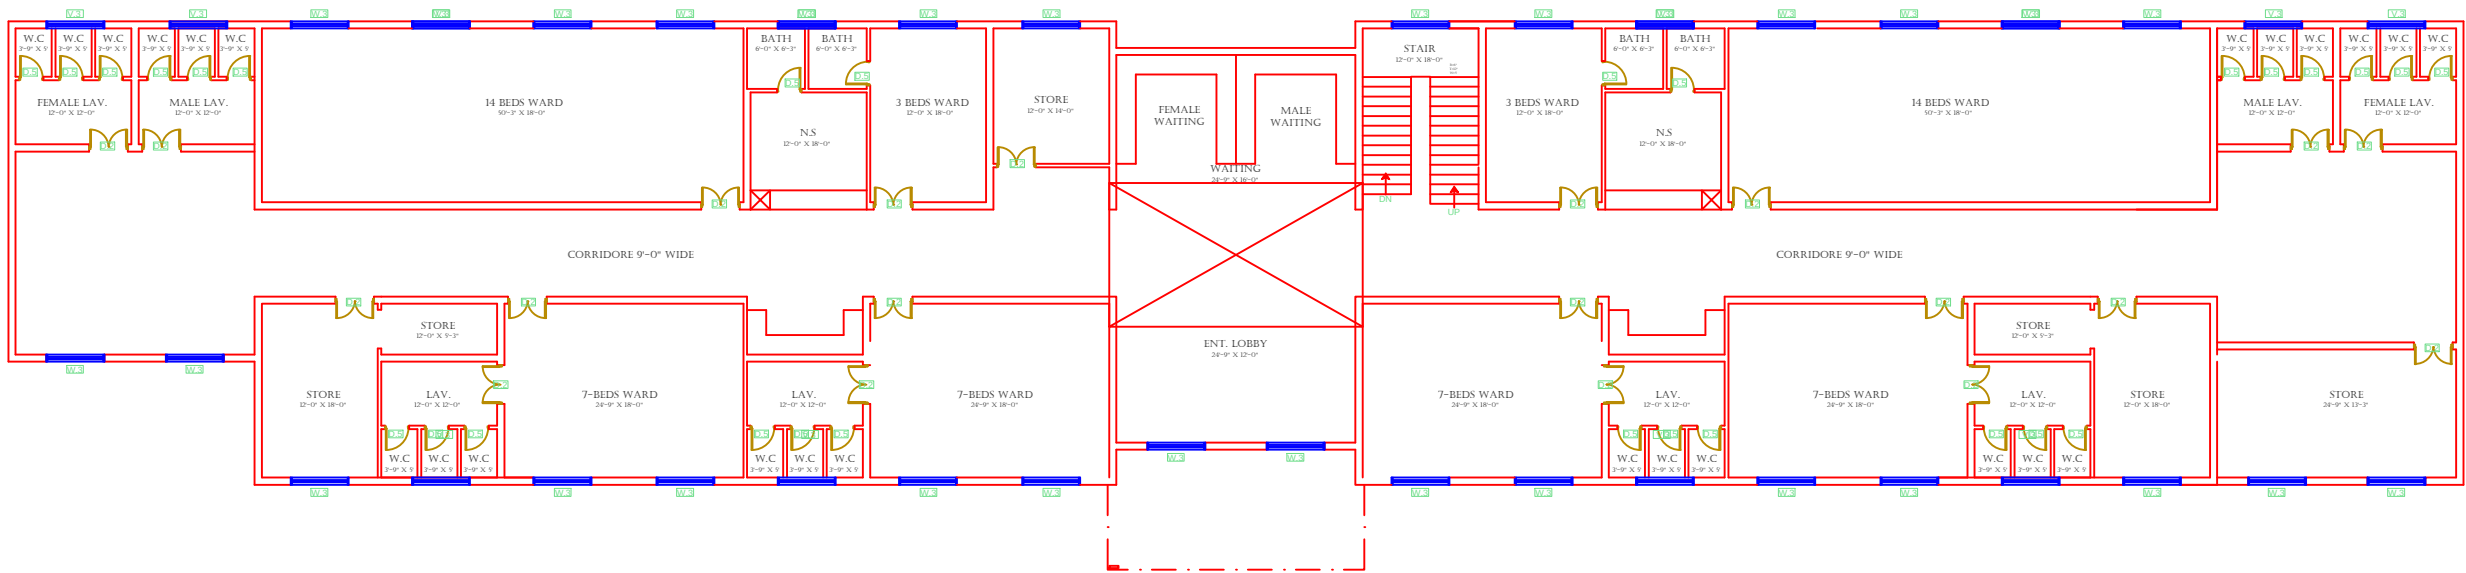

LEGENDS:

RESIDENTIAL AREA

ROAD

WALL

POWER LINE

OHT

TREE

MAN HOLE

TUBE WELL

LIGHT POLE

LAWNS

EARTHEN AREAS

ASPHALTS ROADS

TOUGH PAVERS

P.C.C / PLINTH PROTECTION

BOUNDARY WALL

BRICK PAVERS / SOLING

DRAIN

TAP

HAND PUMP

AIR CONDITIONER

TUBE LIGHT

FAN

ROOF LIGHT

BULB

AREA					
AREA WITHIN BOUNDARY WALL		377148.13 SFT			
AREA OF CLINICAL BLOCK		48029.72 SFT			
PLINTH AREA OF BLOCK		6671.22 SFT			

OPENING SCHEDULE OF DOORS AND WINDOWS					
DOORS	WIDTH	HEIGHT	WINDOWS	WIDTH	HEIGHT
D1	5'-0"	7'-0"	W1	3'-0"	5'-0"
D2	4'-0"	7'-0"	W2	3'-6"	5'-0"
D3	3'-6"	7'-0"	W3	6'-0"	5'-0"
D4	3'-0"	7'-0"	W4	4'-6"	5'-0"
D5	2'-6"	7'-0"	W5	8'-6"	5'-0"
D6	6'-0"	7'-0"	W6	7'-0"	5'-0"
VENTS	WIDTH	HEIGHT	W7	2'-6"	5'-0"
V1	1'-6"	2'-0"	W8	4'-0"	5'-0"
V2	2'-0"	2'-0"	W9	5'-0"	5'-0"
V3	3'-0"	2'-0"	W0	2'-0"	5'-0"

Project:

CAD MAPPING OF TEHSIL
HEAD QUARTER HOSPITALS,
PUNJAB

Client:

GOVERNMENT OF THE PUNJAB
PRIMARY & SECONDARY
HEALTHCARE DEPARTMENT

Consultant:

SKAFS CONSULTANT (Pvt.)
Limited
ENGINEERING AND ENVIRONMENT
CONSULTANT

Drawing Title:


THQ SAMUNDARI
CLINICAL BLOCK PLAN (PART 1)

Drawing No.

SKAFS/SAMUNDARI/13

CLINICAL BLOCK OF THQ HOSPITAL SAMUNDARI

FIRST FLOOR PART 2

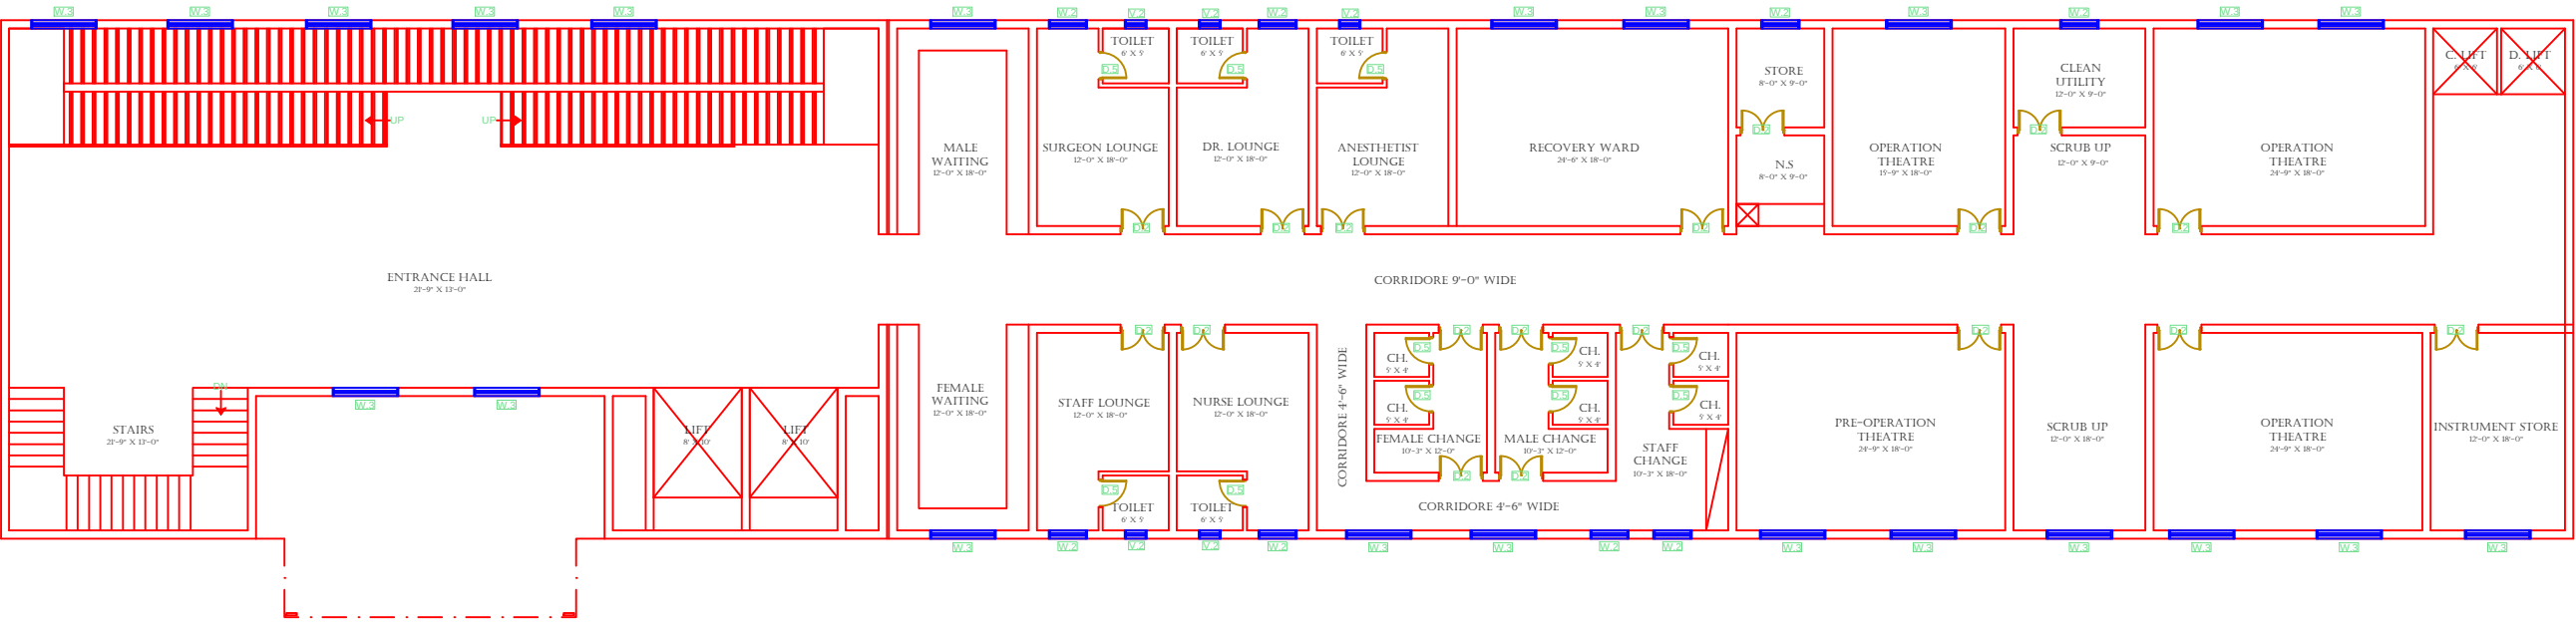

LEGENDS:	
RESIDENTIAL AREA	
ROAD	
WALL	
POWER LINE	
OHT	
TREE	
MAN HOLE	
TUBE WELL	
LIGHT POLE	
LAWNS	
EARTHEN AREAS	
ASPHALTS ROADS	
TOUGH PAVERS	
P.C.C / PLINTH PROTECTION	
BOUNDARY WALL	
BRICK PAVERS / SOLING	
DRAIN	
TAP	
HAND PUMP	
AIR CONDITIONER	
TUBE LIGHT	
FAN	
ROOF LIGHT	
BULB	

AREA	
AREA WITHIN BOUNDARY WALL	377148.13 SFT
AREA OF CLINICAL BLOCK	48029.72 SFT
PLINTH AREA OF BLOCK	6671.22 SFT

OPENING SCHEDULE OF DOORS AND WINDOWS					
DOORS	WIDTH	HEIGHT	WINDOWS	WIDTH	HEIGHT
D1	5'-0"	7'-0"	W1	3'-0"	5'-0"
D2	4'-0"	7'-0"	W2	3'-6"	5'-0"
D3	3'-6"	7'-0"	W3	6'-0"	5'-0"
D4	3'-0"	7'-0"	W4	4'-6"	5'-0"
D5	2'-6"	7'-0"	W5	8'-6"	5'-0"
D6	6'-0"	7'-0"	W6	7'-0"	5'-0"
VENTS	WIDTH	HEIGHT	W7	2'-6"	5'-0"
V1	1'-6"	2'-0"	W8	4'-0"	5'-0"
V2	2'-0"	2'-0"	W9	5'-0"	5'-0"
V3	3'-0"	2'-0"	W0	2'-0"	5'-0"

Project:
**CAD MAPPING OF TEHSIL
HEAD QUARTER HOSPITALS,
PUNJAB**


Client:	Consultant:
 GOVERNMENT OF THE PUNJAB PRIMARY & SECONDARY HEALTHCARE DEPARTMENT	 SKAFS CONSULTANT (Pvt.) Limited ENGINEERING AND ENVIRONMENT CONSULTANT

Drawing Title:
**THQ SAMUNDARI
CLINICAL BLOCK PLAN (PART 2)**

Drawing No.
SKAFS/SAMUNDARI/14

ELECTRICAL LAYOUT OF THQ HOSPITAL SAMUNDARI

GROUND FLOOR

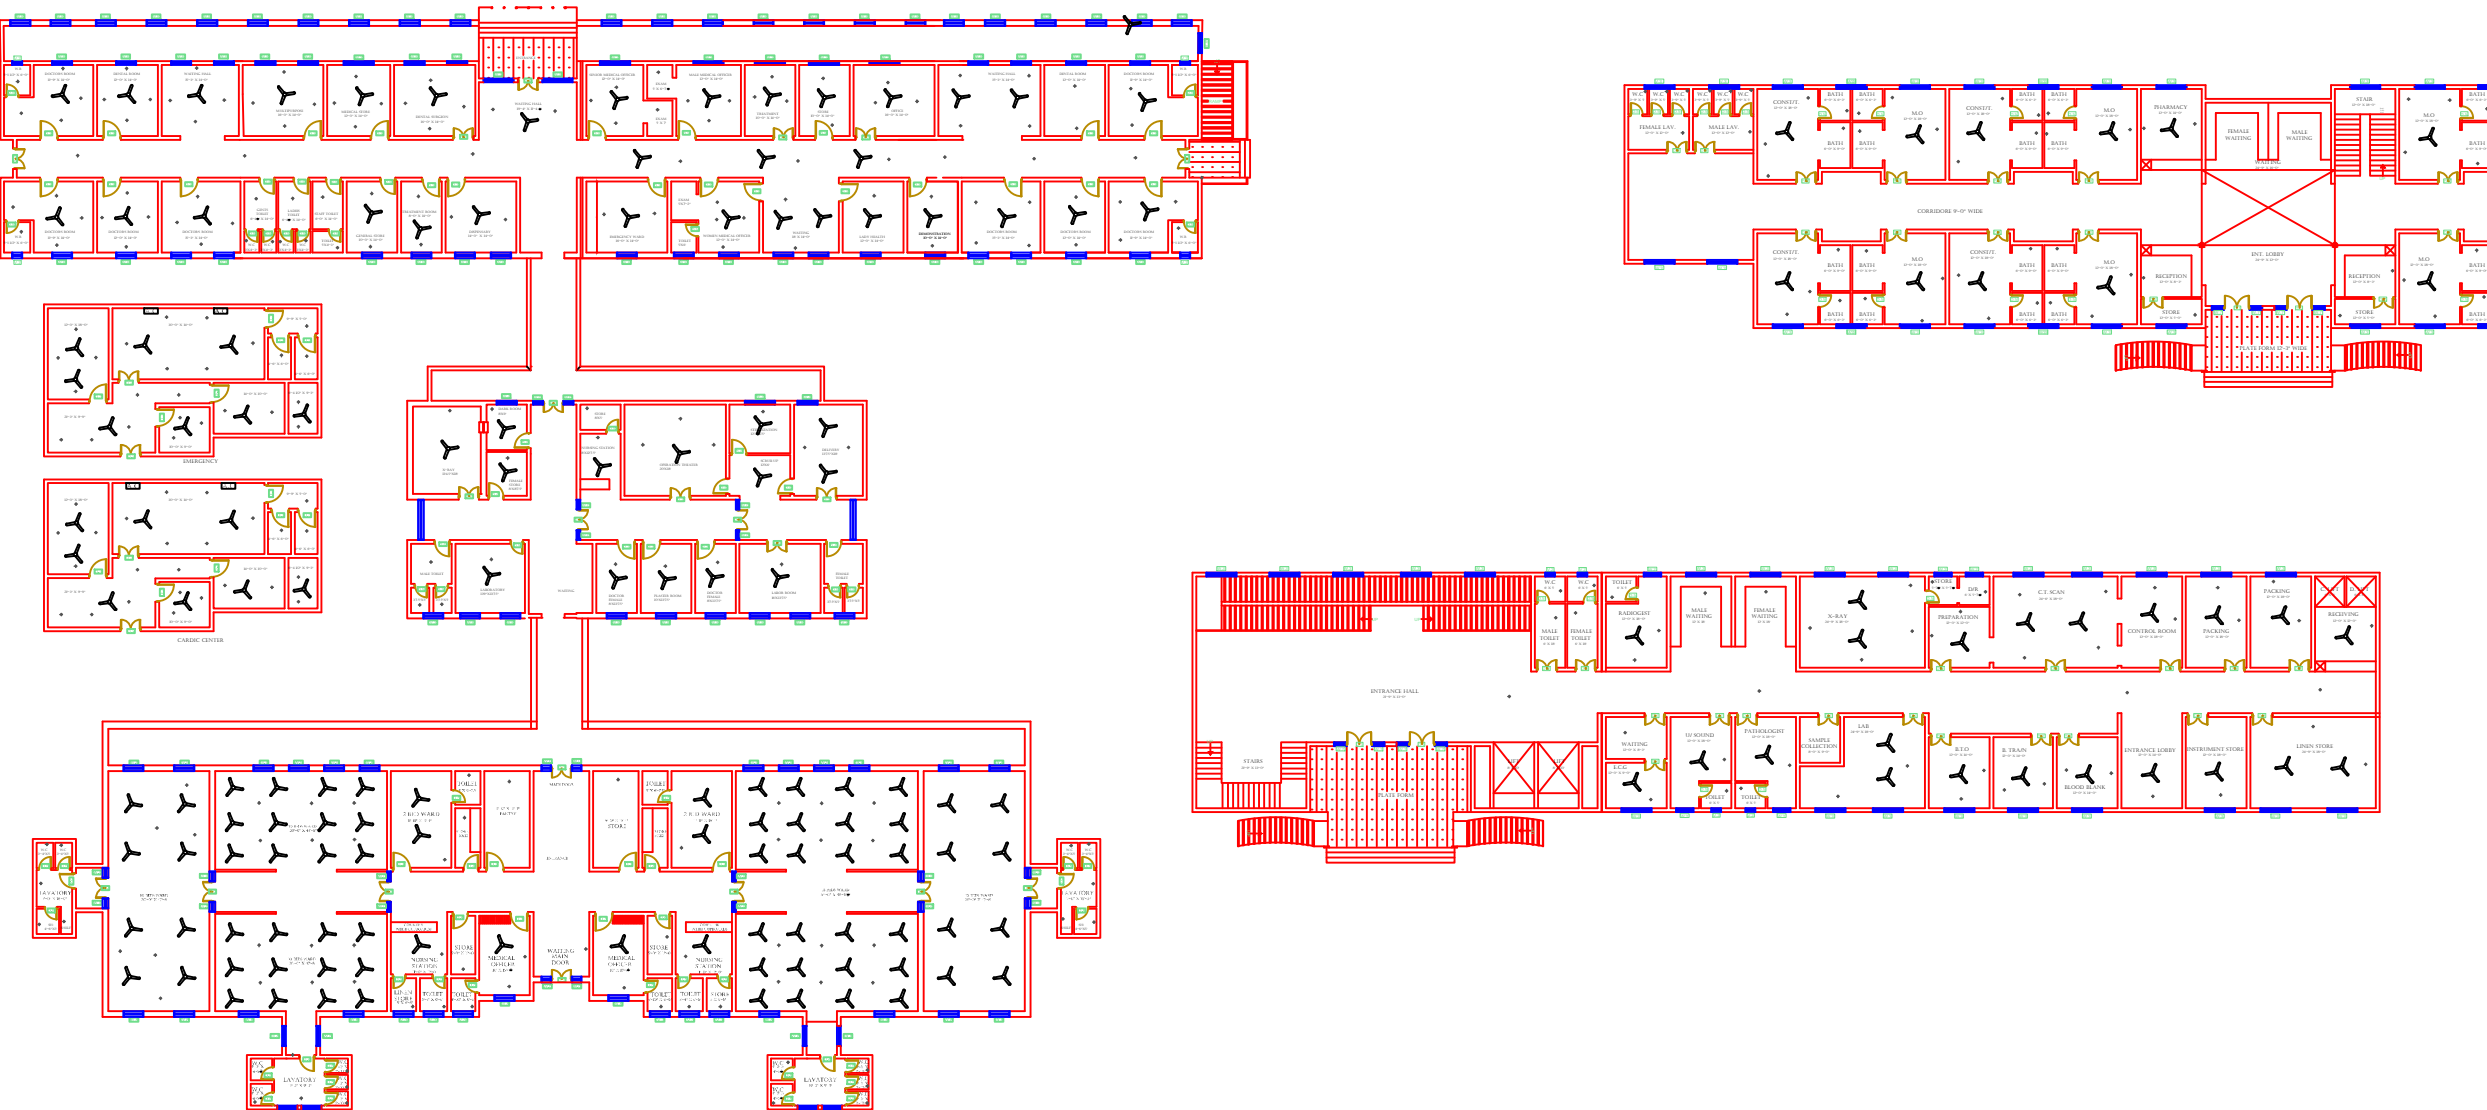

LEGENDS:

RESIDENTIAL AREA	
ROAD	
WALL	
POWER LINE	
OHT	
TREE	
MAN HOLE	
TUBE WELL	
LIGHT POLE	
LAWNS	
EARTHEN AREAS	
ASPHALTS ROADS	
TOUGH PAVERS	
P.C.C / PLINTH PROTECTION	
BOUNDARY WALL	
BRICK PAVERS / SOLING	
DRAIN	
TAP	
HAND PUMP	
AIR CONDITIONER	
TUBE LIGHT	
FAN	
ROOF LIGHT	
BULB	


AREA	
AREA WITHIN BOUNDARY WALL	377148.13 SFT
AREA OF CLINICAL BLOCK	48029.72 SFT
PLINTH AREA OF BLOCK	6671.22 SFT

OPENING SCHEDULE OF DOORS AND WINDOWS					
DOORS	WIDTH	HEIGHT	WINDOWS	WIDTH	HEIGHT
D1	5'-0"	7'-0"	W1	3'-0"	5'-0"
D2	4'-0"	7'-0"	W2	3'-6"	5'-0"
D3	3'-6"	7'-0"	W3	6'-0"	5'-0"
D4	3'-0"	7'-0"	W4	4'-6"	5'-0"
D5	2'-6"	7'-0"	W5	8'-6"	5'-0"
D6	6'-0"	7'-0"	W6	7'-0"	5'-0"
VENTS	WIDTH	HEIGHT	W7	2'-6"	5'-0"
V1	1'-6"	2'-0"	W8	4'-0"	5'-0"
V2	2'-0"	2'-0"	W9	5'-0"	5'-0"
V3	3'-0"	2'-0"	W0	2'-0"	5'-0"

Project:	
CAD MAPPING OF TEHSIL HEAD QUARTER HOSPITALS, PUNJAB	
Client:	Consultant:
 GOVERNMENT OF THE PUNJAB PRIMARY & SECONDARY HEALTHCARE DEPARTMENT	 SKAFS CONSULTANT (Pvt.) Limited ENGINEERING AND ENVIRONMENT CONSULTANT
Drawing Title: THQ SAMUNDARI ELECTRICAL PLAN (GROUND FLOOR)	
Drawing No. SKAFS/SAMUNDARI/15	

ELECTRICAL LAYOUT OF THQ HOSPITAL SAMUNDARI

FIRST FLOOR

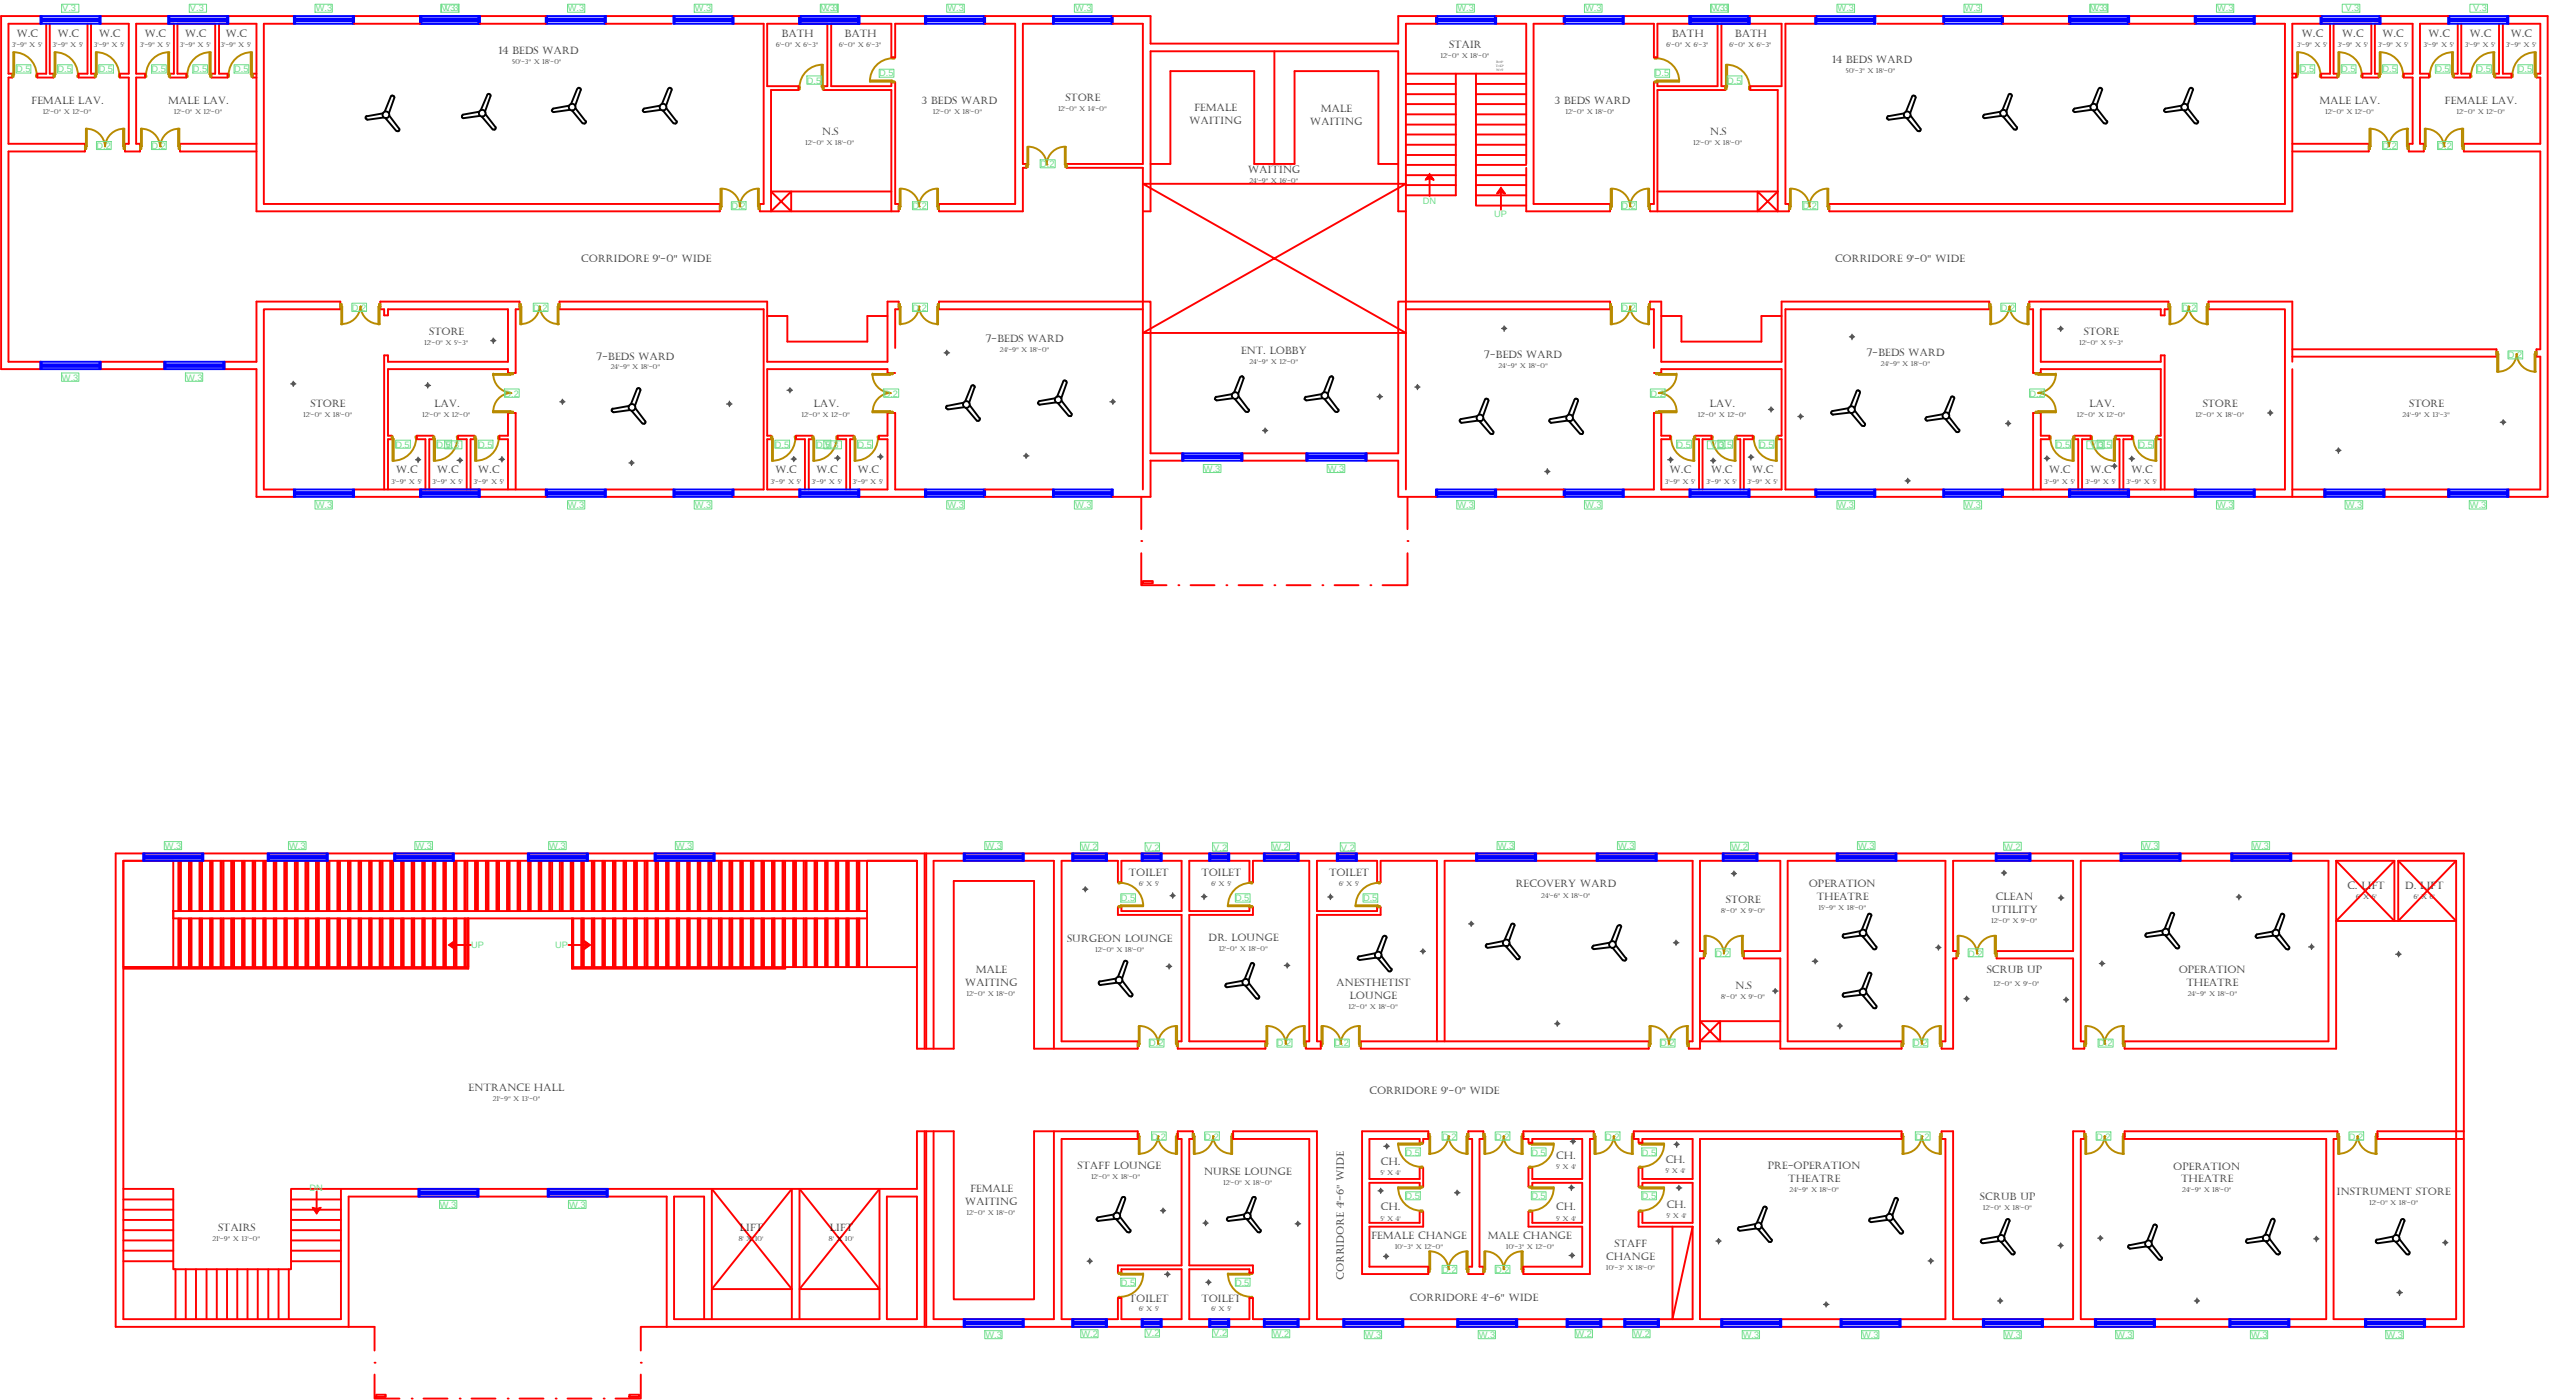

LEGENDS:	
RESIDENTIAL AREA	
ROAD	
WALL	
POWER LINE	
OHT	
TREE	
MAN HOLE	
TUBE WELL	
LIGHT POLE	
LAWNS	
EARTHEN AREAS	
ASPHALTS ROADS	
TOUGH PAVERS	
P.C.C / PLINTH PROTECTION	
BOUNDARY WALL	
BRICK PAVERS / SOLING	
DRAIN	
TAP	
HAND PUMP	
AIR CONDITIONER	
TUBE LIGHT	
FAN	
ROOF LIGHT	
BULB	

AREA	
AREA WITHIN BOUNDARY WALL	377148.13 SFT
AREA OF CLINICAL BLOCK	48029.72 SFT
PLINTH AREA OF BLOCK	6671.22 SFT

OPENING SCHEDULE OF DOORS AND WINDOWS					
DOORS	WIDTH	HEIGHT	WINDOWS	WIDTH	HEIGHT
D1	5'-0"	7'-0"	W1	3'-0"	5'-0"
D2	4'-0"	7'-0"	W2	3'-6"	5'-0"
D3	3'-6"	7'-0"	W3	6'-0"	5'-0"
D4	3'-0"	7'-0"	W4	4'-6"	5'-0"
D5	2'-6"	7'-0"	W5	8'-6"	5'-0"
D6	6'-0"	7'-0"	W6	7'-0"	5'-0"
VENTS	WIDTH	HEIGHT	W7	2'-6"	5'-0"
V1	1'-6"	2'-0"	W8	4'-0"	5'-0"
V2	2'-0"	2'-0"	W9	5'-0"	5'-0"
V3	3'-0"	2'-0"	W0	2'-0"	5'-0"

Project:
**CAD MAPPING OF TEHSIL
HEAD QUARTER HOSPITALS,
PUNJAB**

Client: GOVERNMENT OF THE PUNJAB PRIMARY & SECONDARY HEALTHCARE DEPARTMENT	Consultant: SKAFS CONSULTANT (Pvt.) Limited ENGINEERING AND ENVIRONMENT CONSULTANT
---	--

Drawing Title:
**THQ SAMUNDARI
ELECTRICAL PLAN (FIRST FLOOR)**

Drawing No.
SKAFS/SAMUNDARI/16