

MASTER PLAN OF THQ HOSPITAL GUJAR KHAN

PART 1

PART 2

PART 3

PART 4



Legends:

RESIDENTIAL AREA	
ROAD	
WALL	
POWER LINE	
OHT	
TREE	
MANHOLE	
TUBE WELL	
LIGHT POLE	
LAWNS	
EARTHEN AREAS	
ASPHALTS ROADS	
TOUGH PAVERS	
P.C.C /PLINTH PROTECTION	
BOUNDARY WALL	
TAP	
HAND PUMP	
BRICK PAVERS	
AIR CONDITIONER	
TUBE LIGHT	
FAN	
ROOF LIGHT	
BULB	

AREA	
AREA WITHIN BOUNDARY WALL	255225.47 SFT
AREA OF CLINICAL BLOCK	146477.89 SFT
PLINTH AREA OF BLOCK	89148.993 SFT

OPENING SCHEDULE OF DOORS AND WINDOWS					
DOORS	WIDTH	HEIGHT	WINDOWS	WIDTH	HEIGHT
D1	2'-6"	7'-0"	W1	2'-6"	2'-6"
D2	3'-0"	7'-0"	W2	3'-0"	3'-0"
D3	3'-6"	7'-0"	W3	4'-0"	4'-0"
D4	4'-0"	7'-0"	W4	5'-0"	5'-0"
D5	5'-0"	7'-0"	W5	6'-0"	6'-0"
D6	6'-0"	7'-0"	W6	8'-0"	8'-0"
D7	7'-0"	7'-0"	W7	9'-0"	9'-0"
D8	8'-0"	7'-0"	V1		
D9			V2		

Client:

GOVERNMENT OF THE PUNJAB
PRIMARY & SECONDARY
HEALTHCARE DEPARTMENT

Project:

CAD MAPPING OF TEHSIL
HEAD QUARTER HOSPITALS,
PUNJAB

Consultant:

SKAFS CONSULTANT (Pvt.) Limited
ENGINEERING AND ENVIRONMENT CONSULTANT


Drawing Title:



THQ GUJARKHAN
HOSPITAL MASTER PLAN

Authorized By: SKAFS	Reviewed By Co-Team Leader	Scale: 1:300
Prepared By: CAD TEAMS	Date: FEB, 2017	
Drawing No. SKAFS/GUJARKHAN/03		

MASTER PLAN OF THQ HOSPITAL GUJAR KHAN

  PART 1

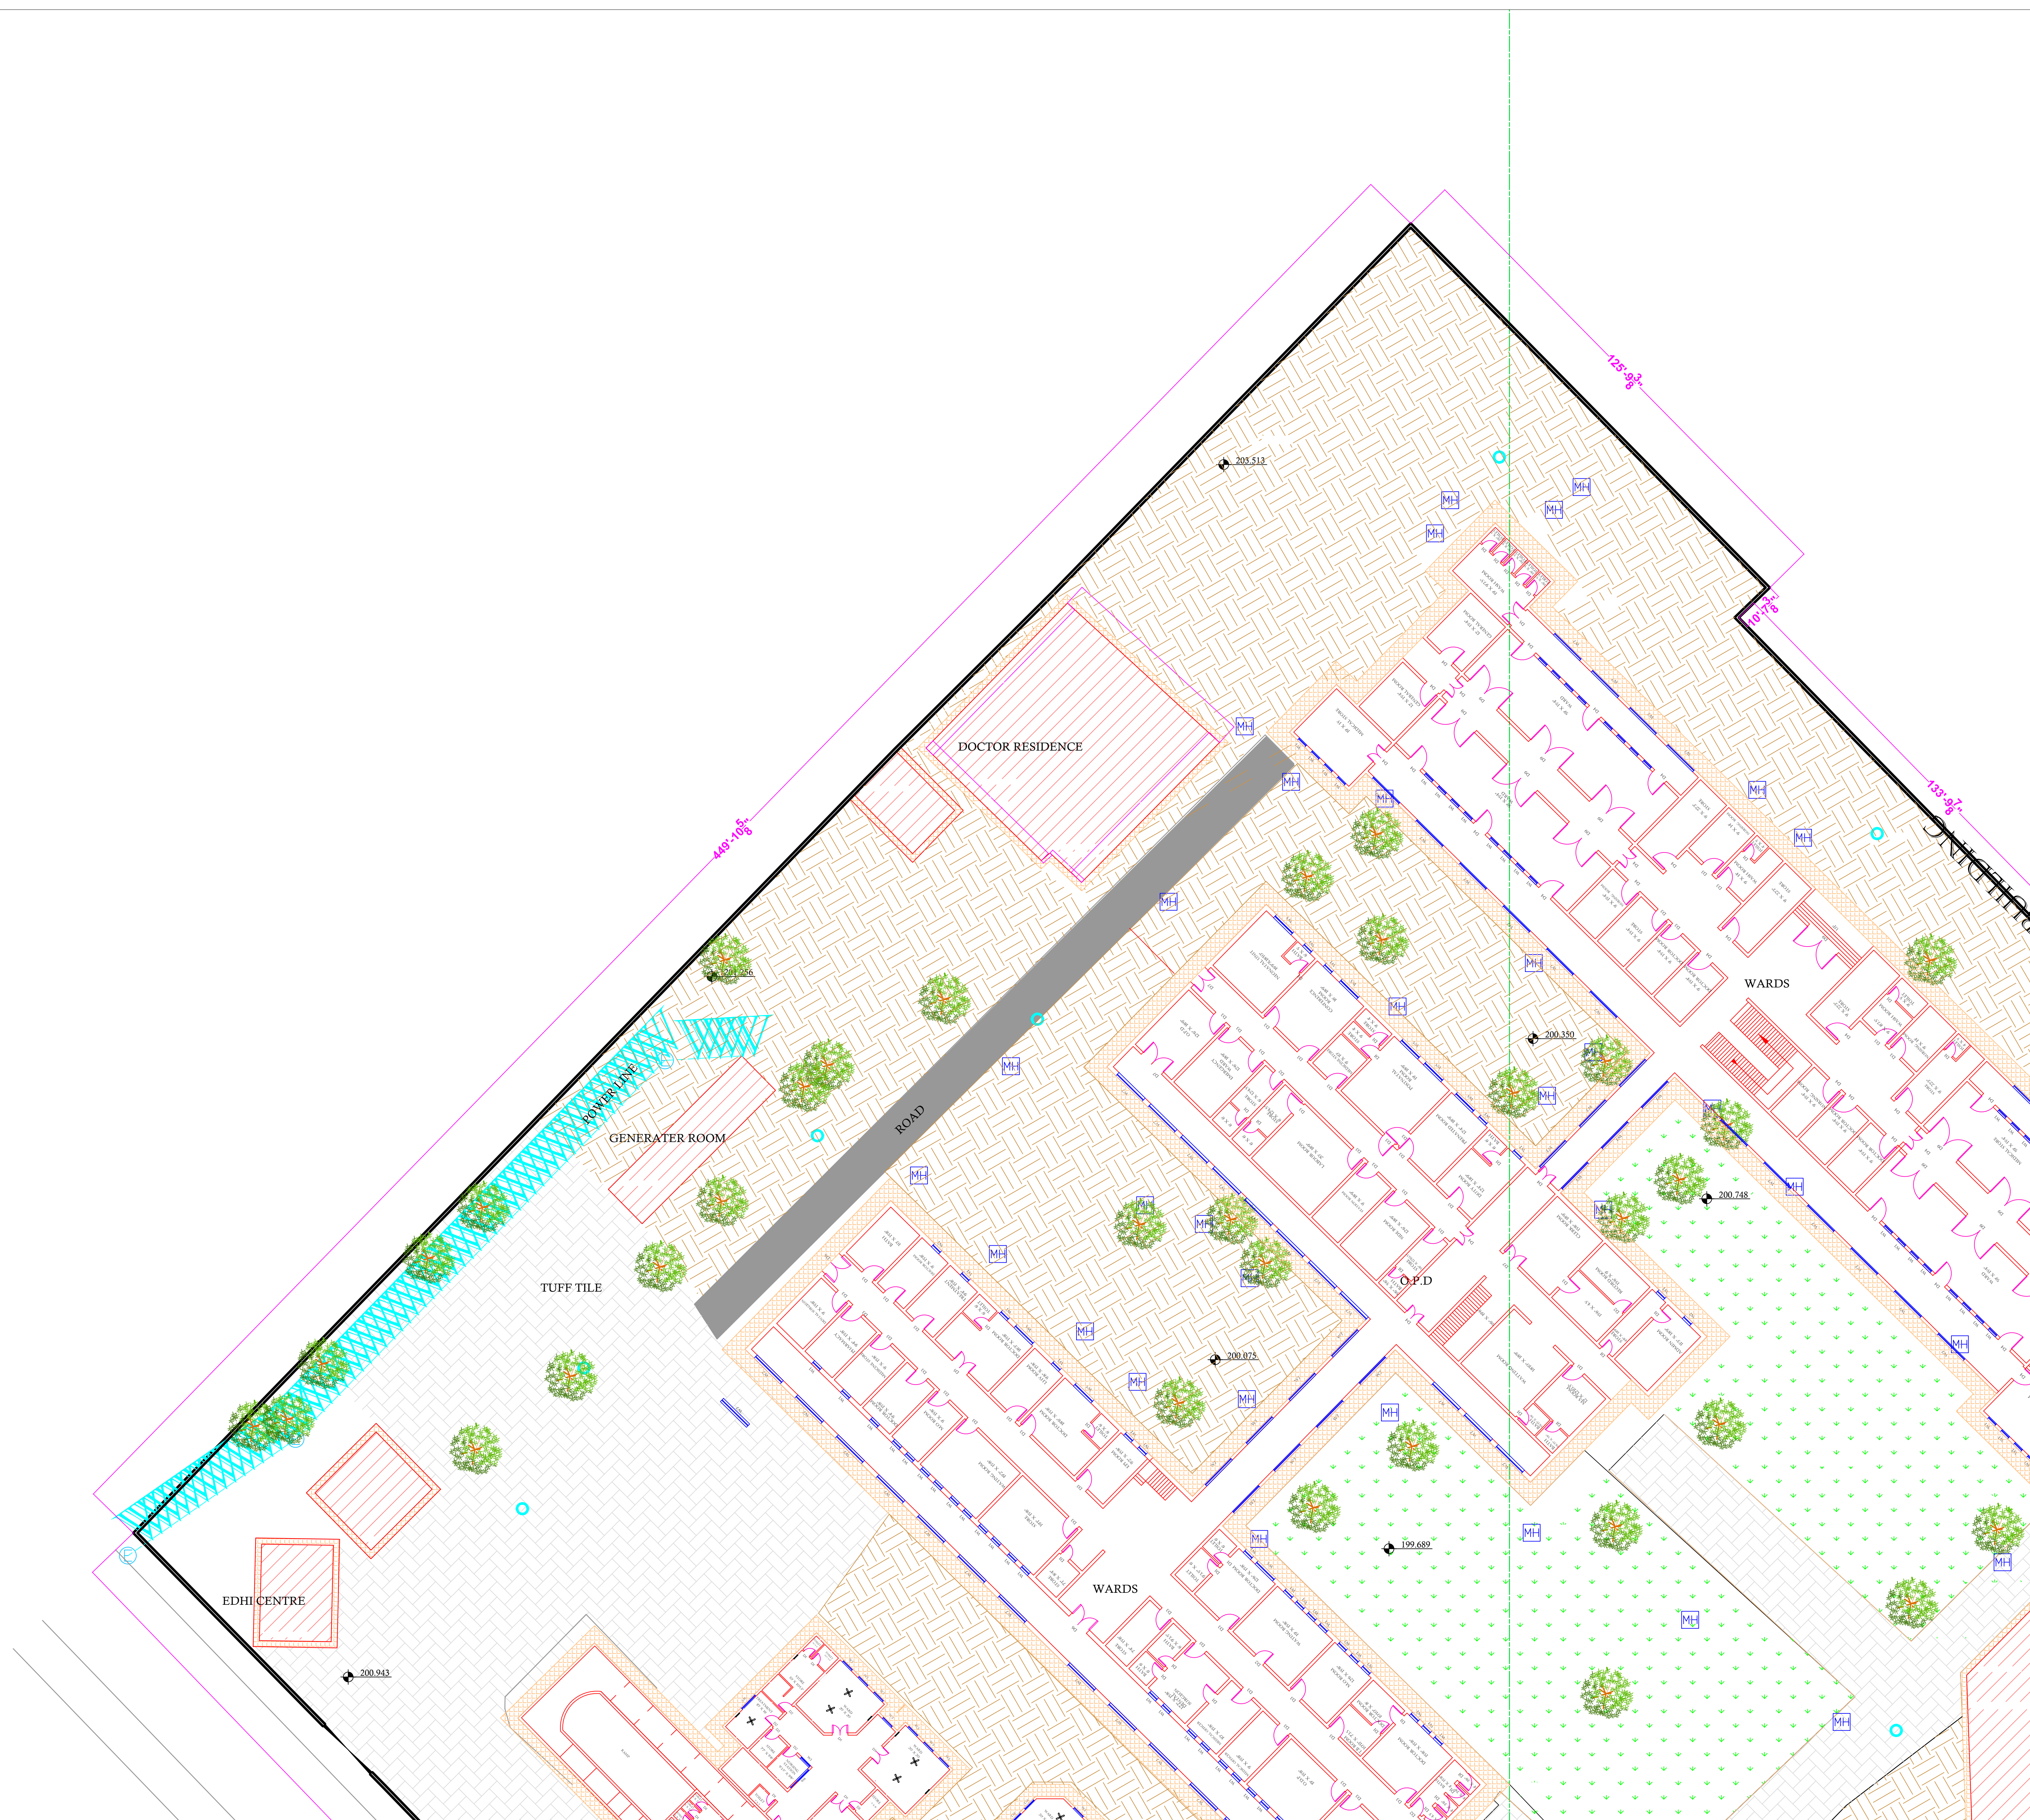

Legends:	
RESIDENTIAL AREA	
ROAD	
WALL	
POWER LINE	
OHT	
TREE	
MANHOLE	
TUBE WELL	
LIGHT POLE	
LAWNS	
EARTHEN AREAS	
ASPHALTS ROADS	
TOUGH PAVERS	
P.C.C /PLINTH PROTECTION	
BOUNDARY WALL	
TAP	
HAND PUMP	
BRICK PAVERS	
AIR CONDITIONER	
TUBE LIGHT	
FAN	
ROOF LIGHT	
BULB	

AREA	
AREA WITHIN BOUNDARY WALL	255225.47 SFT
AREA OF CLINICAL BLOCK	146477.89 SFT
PLINTH AREA OF BLOCK	89148.993 SFT

OPENING SCHEDULE OF DOORS AND WINDOWS					
DOORS	WIDTH	HEIGHT	WINDOWS	WIDTH	HEIGHT
D1	2'-6"	7'-0"	W1	2'-6"	2'-6"
D2	3'-0"	7'-0"	W2	3'-0"	3'-0"
D3	3'-6"	7'-0"	W3	4'-0"	4'-0"
D4	4'-0"	7'-0"	W4	5'-0"	5'-0"
D5	5'-0"	7'-0"	W5	6'-0"	6'-0"
D6	6'-0"	7'-0"	W6	8'-0"	8'-0"
D7	7'-0"	7'-0"	W7	9'-0"	9'-0"
D8	8'-0"	7'-0"	V1		
D9			V2		

Client:



GOVERNMENT OF THE PUNJAB
PRIMARY & SECONDARY
HEALTHCARE DEPARTMENT

Project:	
----------	--

CAD MAPPING OF TEHSIL HEAD QUARTER HOSPITALS, PUNJAB

Consultant:




SKAFS CONSULTANT (Pvt.) Limited
ENGINEERING AND ENVIRONMENT CONSULTANT

Drawing Title: **THQ GUJARKHAN
HOSPITAL MASTER PLAN
PART 1**

Authorized By: SKAFS	Reviewed By Co-Team Leader	Scale:
Prepared By: CAD TEAMS	Date: FEB, 2017	Sheet:
Drawing No.		

MASTER PLAN OF THQ HOSPITAL GUJAR KHAN

PART 2

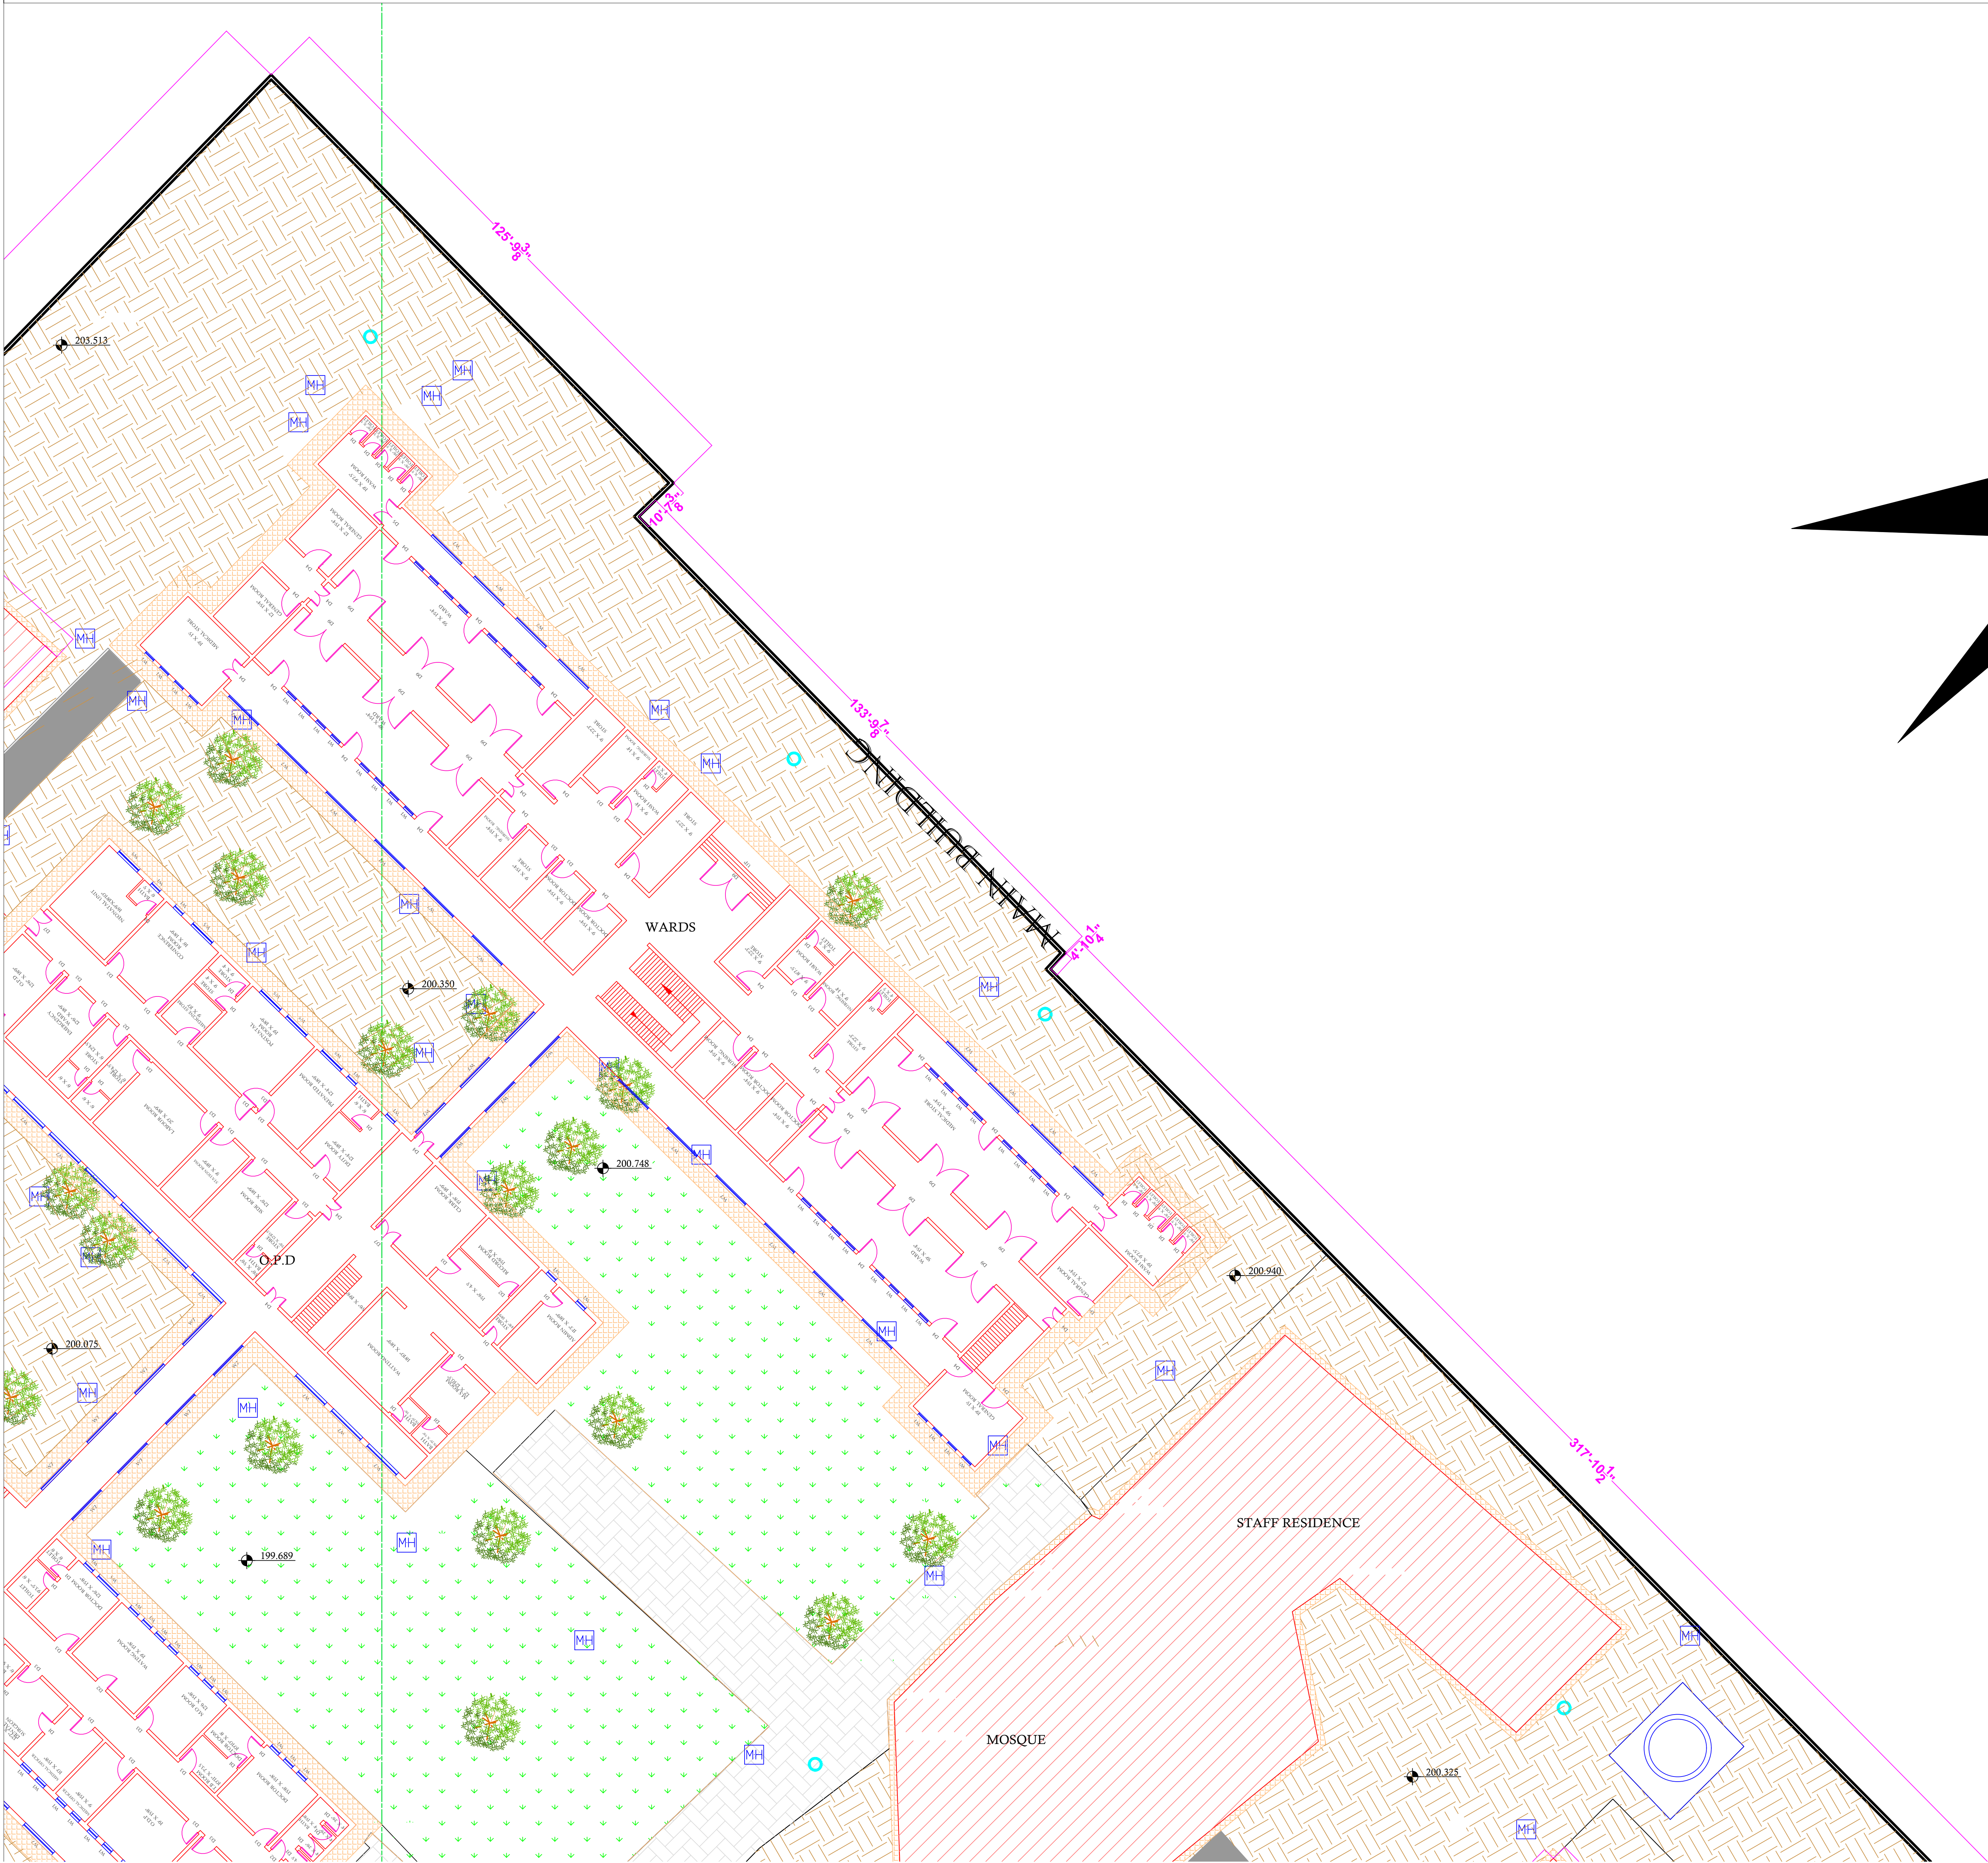

Legends:

RESIDENTIAL AREA	
ROAD	
WALL	
POWER LINE	
OHT	
TREE	
MANHOLE	
TUBE WELL	
LIGHT POLE	
LAWNS	
EARTHEN AREAS	
ASPHALTS ROADS	
TOUGH PAVERS	
P.C.C /PLINTH PROTECTION	
BOUNDARY WALL	
TAP	
HAND PUMP	
BRICK PAVERS	
AIR CONDITIONER	
TUBE LIGHT	
FAN	
ROOF LIGHT	
BULB	

AREA	
AREA WITHIN BOUNDARY WALL	255225.47 SFT
AREA OF CLINICAL BLOCK	146477.89 SFT
PLINTH AREA OF BLOCK	89148.993 SFT

OPENING SCHEDULE OF DOORS AND WINDOWS					
DOORS	WIDTH	HEIGHT	WINDOWS	WIDTH	HEIGHT
D1	2'-6"	7'-0"	W1	2'-6"	2'-6"
D2	3'-0"	7'-0"	W2	3'-0"	3'-0"
D3	3'-6"	7'-0"	W3	4'-0"	4'-0"
D4	4'-0"	7'-0"	W4	5'-0"	5'-0"
D5	5'-0"	7'-0"	W5	6'-0"	6'-0"
D6	6'-0"	7'-0"	W6	8'-0"	8'-0"
D7	7'-0"	7'-0"	W7	9'-0"	9'-0"
D8	8'-0"	7'-0"	V1		
D9			V2		

Client:



GOVERNMENT OF THE PUNJAB
PRIMARY & SECONDARY
HEALTHCARE DEPARTMENT

Project:

CAD MAPPING OF TEHSIL
HEAD QUARTER HOSPITALS,
PUNJAB

Consultant:



SKAFS CONSULTANT (Pvt.) Limited
ENGINEERING AND ENVIRONMENT CONSULTANT

Drawing Title:

THQ GUJARKHAN
HOSPITAL MASTER PLAN
PART 2


Authorized By: SKAFS	Reviewed By Co-Team Leader	Scale:
-------------------------	-------------------------------	--------

Prepared By: CAD TEAMS	Date: FEB, 2017	Sheet:
---------------------------	--------------------	--------

Drawing No. **SKAFS/GUJARKHAN/05**

MASTER PLAN OF THQ HOSPITAL GUJAR KHAN

PART 3

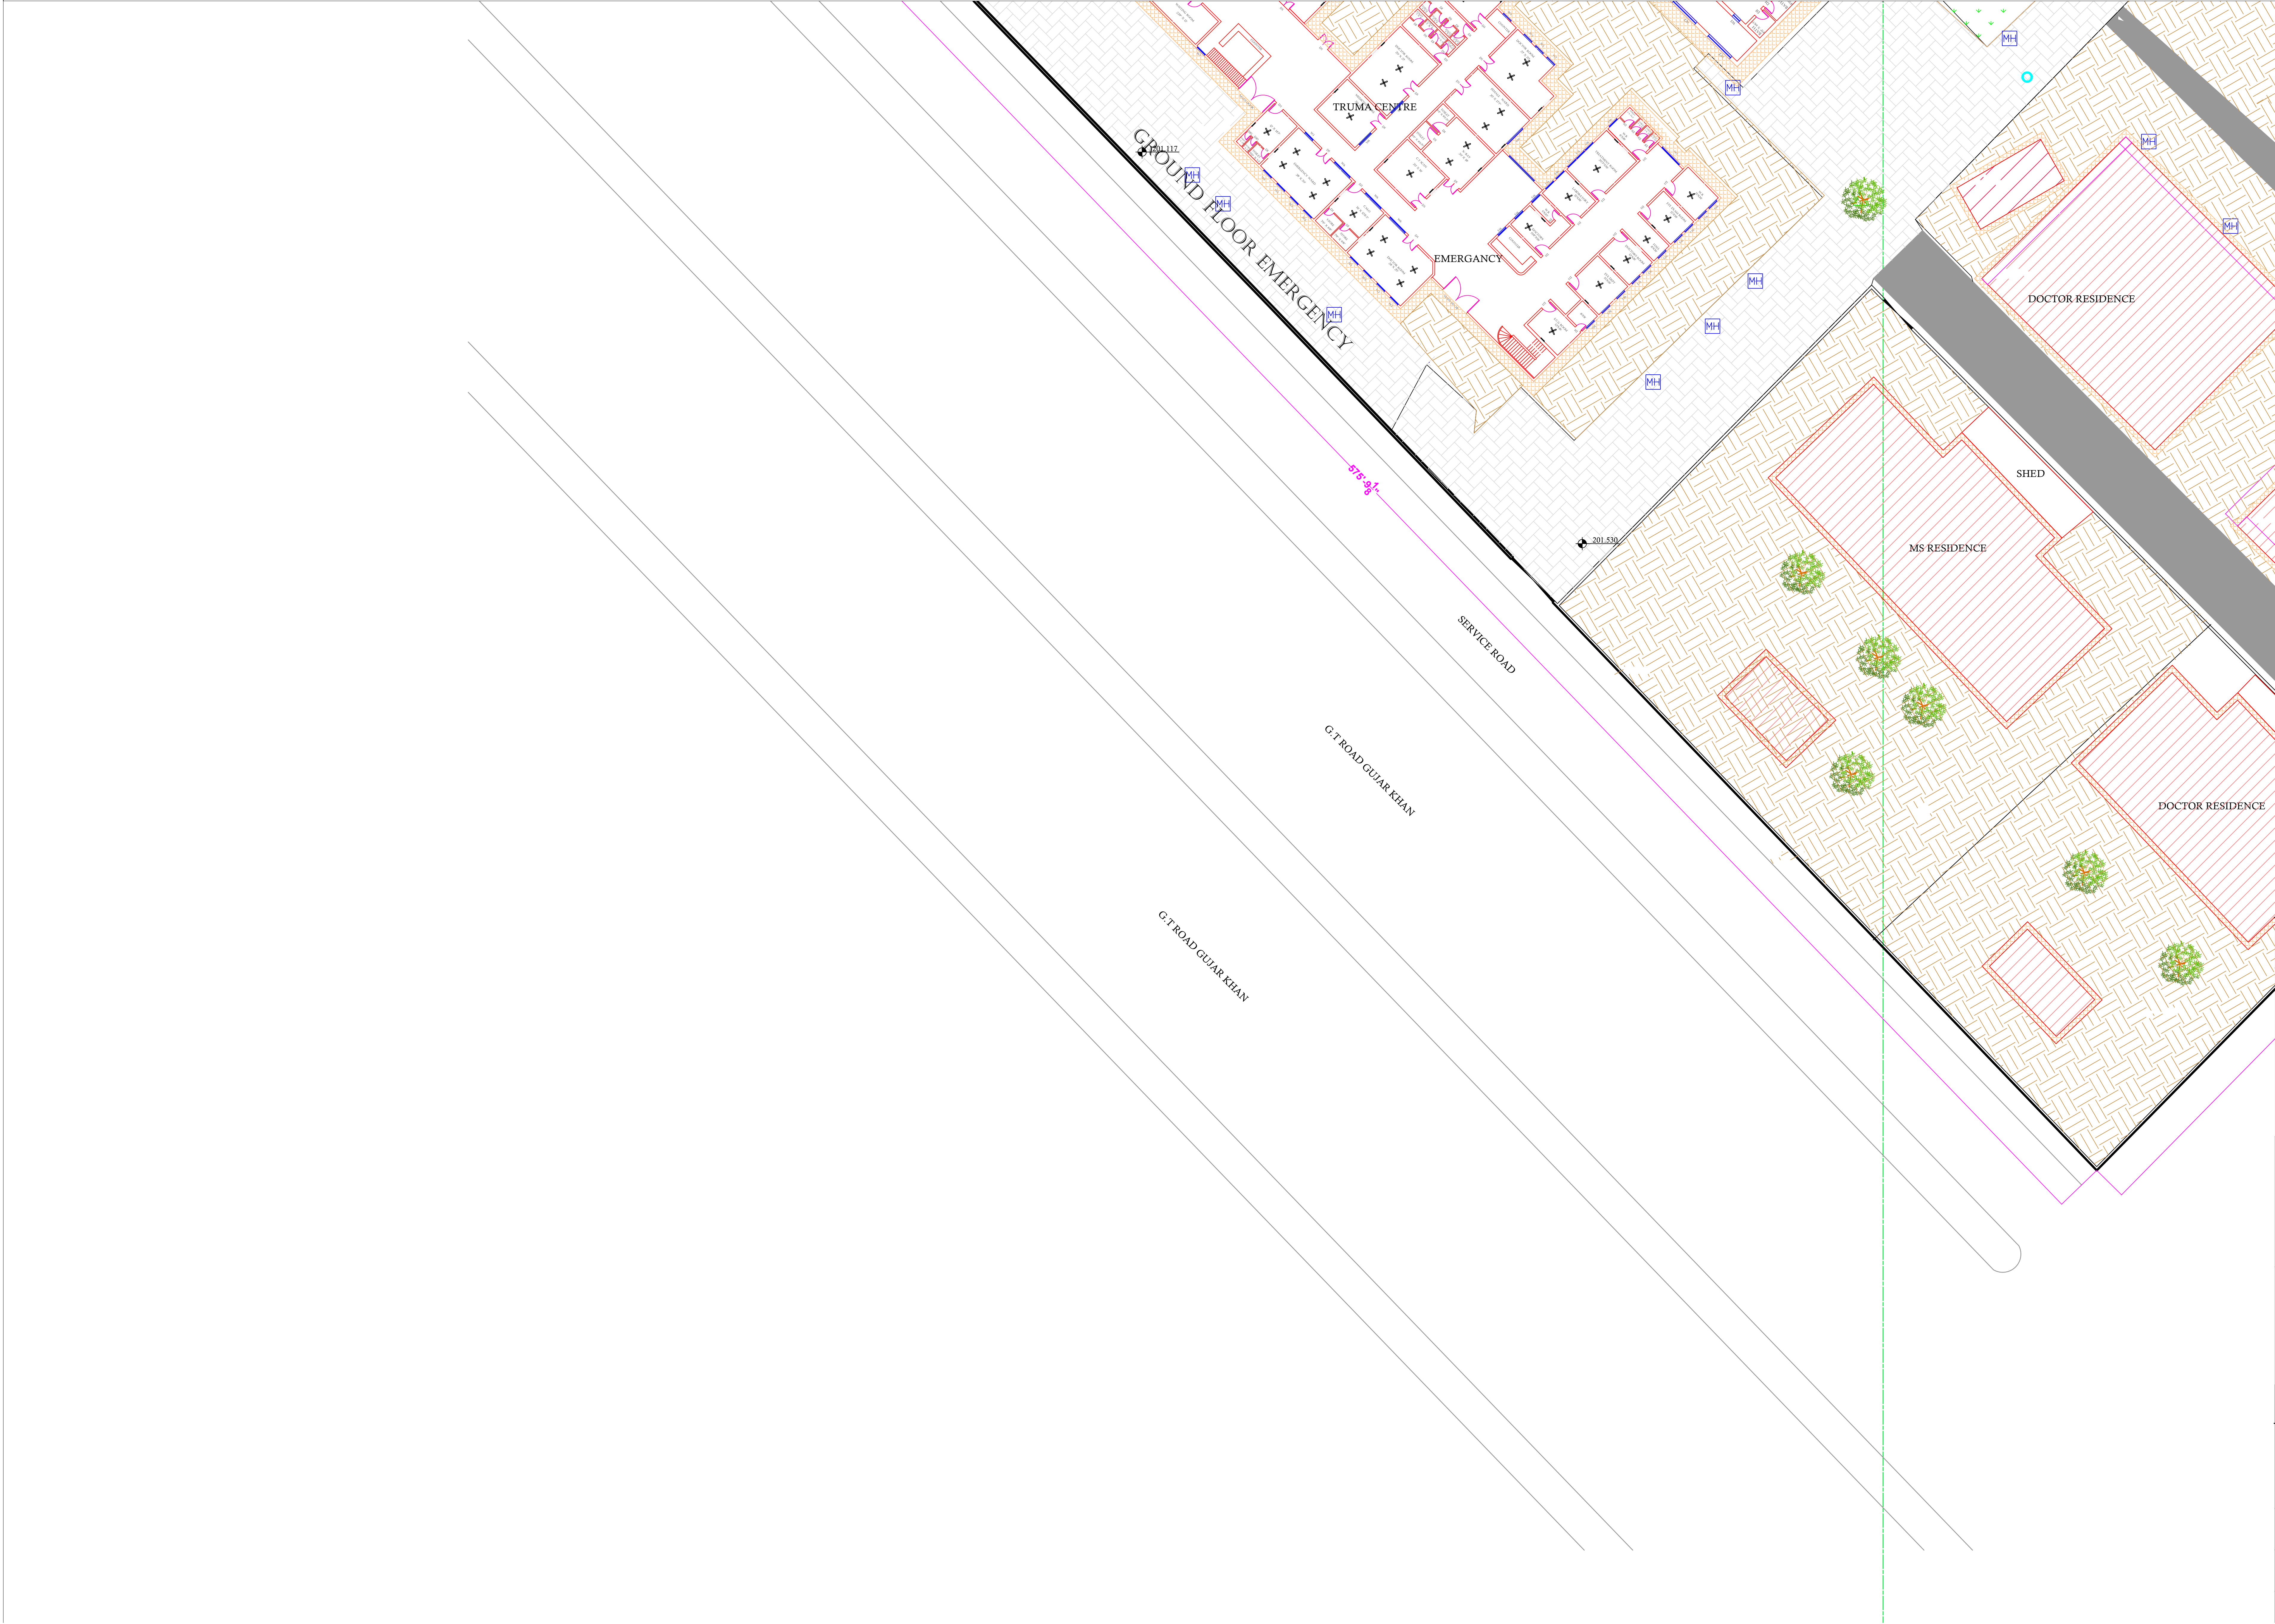

Legends:

RESIDENTIAL AREA	
ROAD	
WALL	
POWER LINE	
OHT	
TREE	
MANHOLE	
TUBE WELL	
LIGHT POLE	
LAWNS	
EARTHEN AREAS	
ASPHALTS ROADS	
TOUGH PAVERS	
P.C.C /PLINTH PROTECTION	
BOUNDARY WALL	
TAP	
HAND PUMP	
BRICK PAVERS	
AIR CONDITIONER	
TUBE LIGHT	
FAN	
ROOF LIGHT	
BULB	

AREA	
AREA WITHIN BOUNDARY WALL	255225.47 SFT
AREA OF CLINICAL BLOCK	146477.89 SFT
PLINTH AREA OF BLOCK	89148.993 SFT

OPENING SCHEDULE OF DOORS AND WINDOWS					
DOORS	WIDTH	HEIGHT	WINDOWS	WIDTH	HEIGHT
D1	2'-6"	7'-0"	W1	2'-6"	2'-6"
D2	3'-0"	7'-0"	W2	3'-0"	3'-0"
D3	3'-6"	7'-0"	W3	4'-0"	4'-0"
D4	4'-0"	7'-0"	W4	5'-0"	5'-0"
D5	5'-0"	7'-0"	W5	6'-0"	6'-0"
D6	6'-0"	7'-0"	W6	8'-0"	8'-0"
D7	7'-0"	7'-0"	W7	9'-0"	9'-0"
D8	8'-0"	7'-0"	V1		
D9			V2		

Client:



GOVERNMENT OF THE PUNJAB
PRIMARY & SECONDARY
HEALTHCARE DEPARTMENT

Project:

CAD MAPPING OF TEHSIL
HEAD QUARTER HOSPITALS,
PUNJAB

Consultant:



SKAFS CONSULTANT (Pvt.) Limited
ENGINEERING AND ENVIRONMENT CONSULTANT

Drawing Title:

THQ GUJARKHAN
HOSPITAL MASTER PLAN
PART 3

Authorized By: SKAFS	Reviewed By Co-Team Leader	Scale:
Prepared By: CAD TEAMS	Date: FEB, 2017	
Drawing No.		SKAFS/GUJARKHAN/06

MASTER PLAN OF THQ HOSPITAL GUJAR KHAN

PART 4



Legends:

RESIDENTIAL AREA	
ROAD	
WALL	
POWER LINE	
OHT	
TREE	
MANHOLE	
TUBE WELL	
LIGHT POLE	
LAWNS	
EARTHEN AREAS	
ASPHALTS ROADS	
TOUGH PAVERS	
P.C.C /PLINTH PROTECTION	
BOUNDARY WALL	
TAP	
HAND PUMP	
BRICK PAVERS	
AIR CONDITIONER	
TUBE LIGHT	
FAN	
ROOF LIGHT	
BULB	

AREA	
AREA WITHIN BOUNDARY WALL	255225.47 SFT
AREA OF CLINICAL BLOCK	146477.89 SFT
PLINTH AREA OF BLOCK	89148.993 SFT

OPENING SCHEDULE OF DOORS AND WINDOWS					
DOORS	WIDTH	HEIGHT	WINDOWS	WIDTH	HEIGHT
D1	2'-6"	7'-0"	W1	2'-6"	2'-6"
D2	3'-0"	7'-0"	W2	3'-0"	3'-0"
D3	3'-6"	7'-0"	W3	4'-0"	4'-0"
D4	4'-0"	7'-0"	W4	5'-0"	5'-0"
D5	5'-0"	7'-0"	W5	6'-0"	6'-0"
D6	6'-0"	7'-0"	W6	8'-0"	8'-0"
D7	7'-0"	7'-0"	W7	9'-0"	9'-0"
D8	8'-0"	7'-0"	V1		
D9			V2		

Client:

GOVERNMENT OF THE PUNJAB
PRIMARY & SECONDARY
HEALTHCARE DEPARTMENT

Project:

CAD MAPPING OF TEHSIL
HEAD QUARTER HOSPITALS,
PUNJAB

Consultant:

SKAFS CONSULTANT (Pvt.) Limited
ENGINEERING AND ENVIRONMENT CONSULTANT

Drawing Title:

THQ GUJARKHAN
HOSPITAL MASTER PLAN
PART 4

Authorized By: SKAFS	Reviewed By Co-Team Leader	Scale:
Prepared By: CAD TEAMS	Date: FEB, 2017	


Drawing No.

SKAFS/GUJARKHAN/07


CLINICAL BLOCK OF THQ HOSPITAL GUJAR KHAN

GROUND FLOOR


PART 4

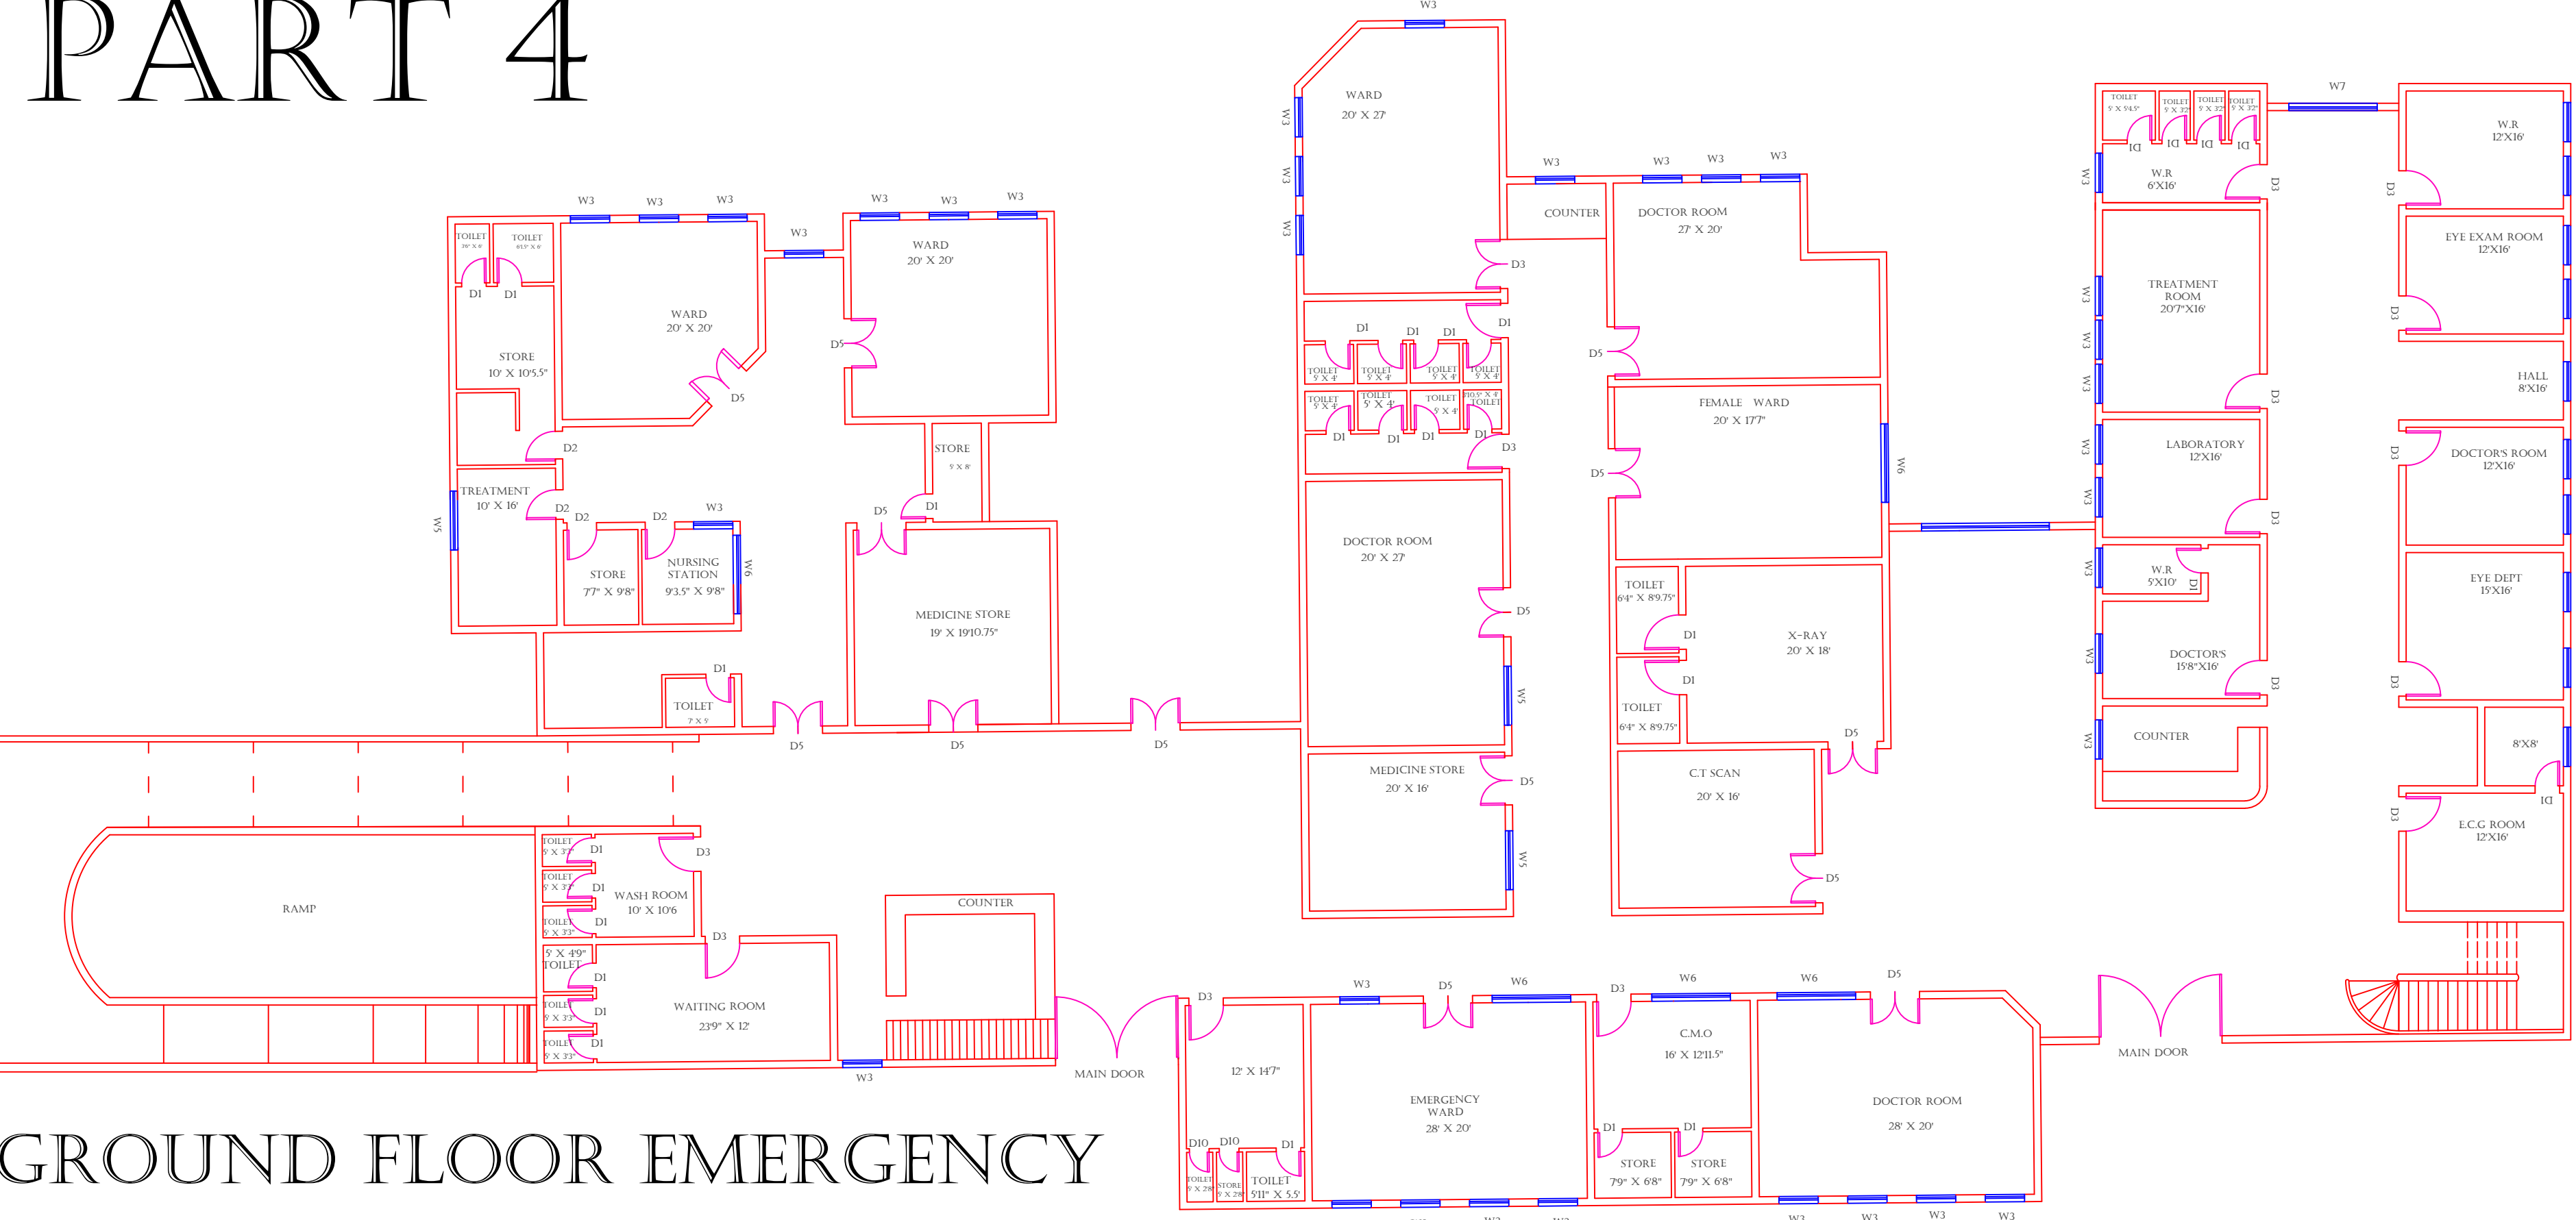


PART 1

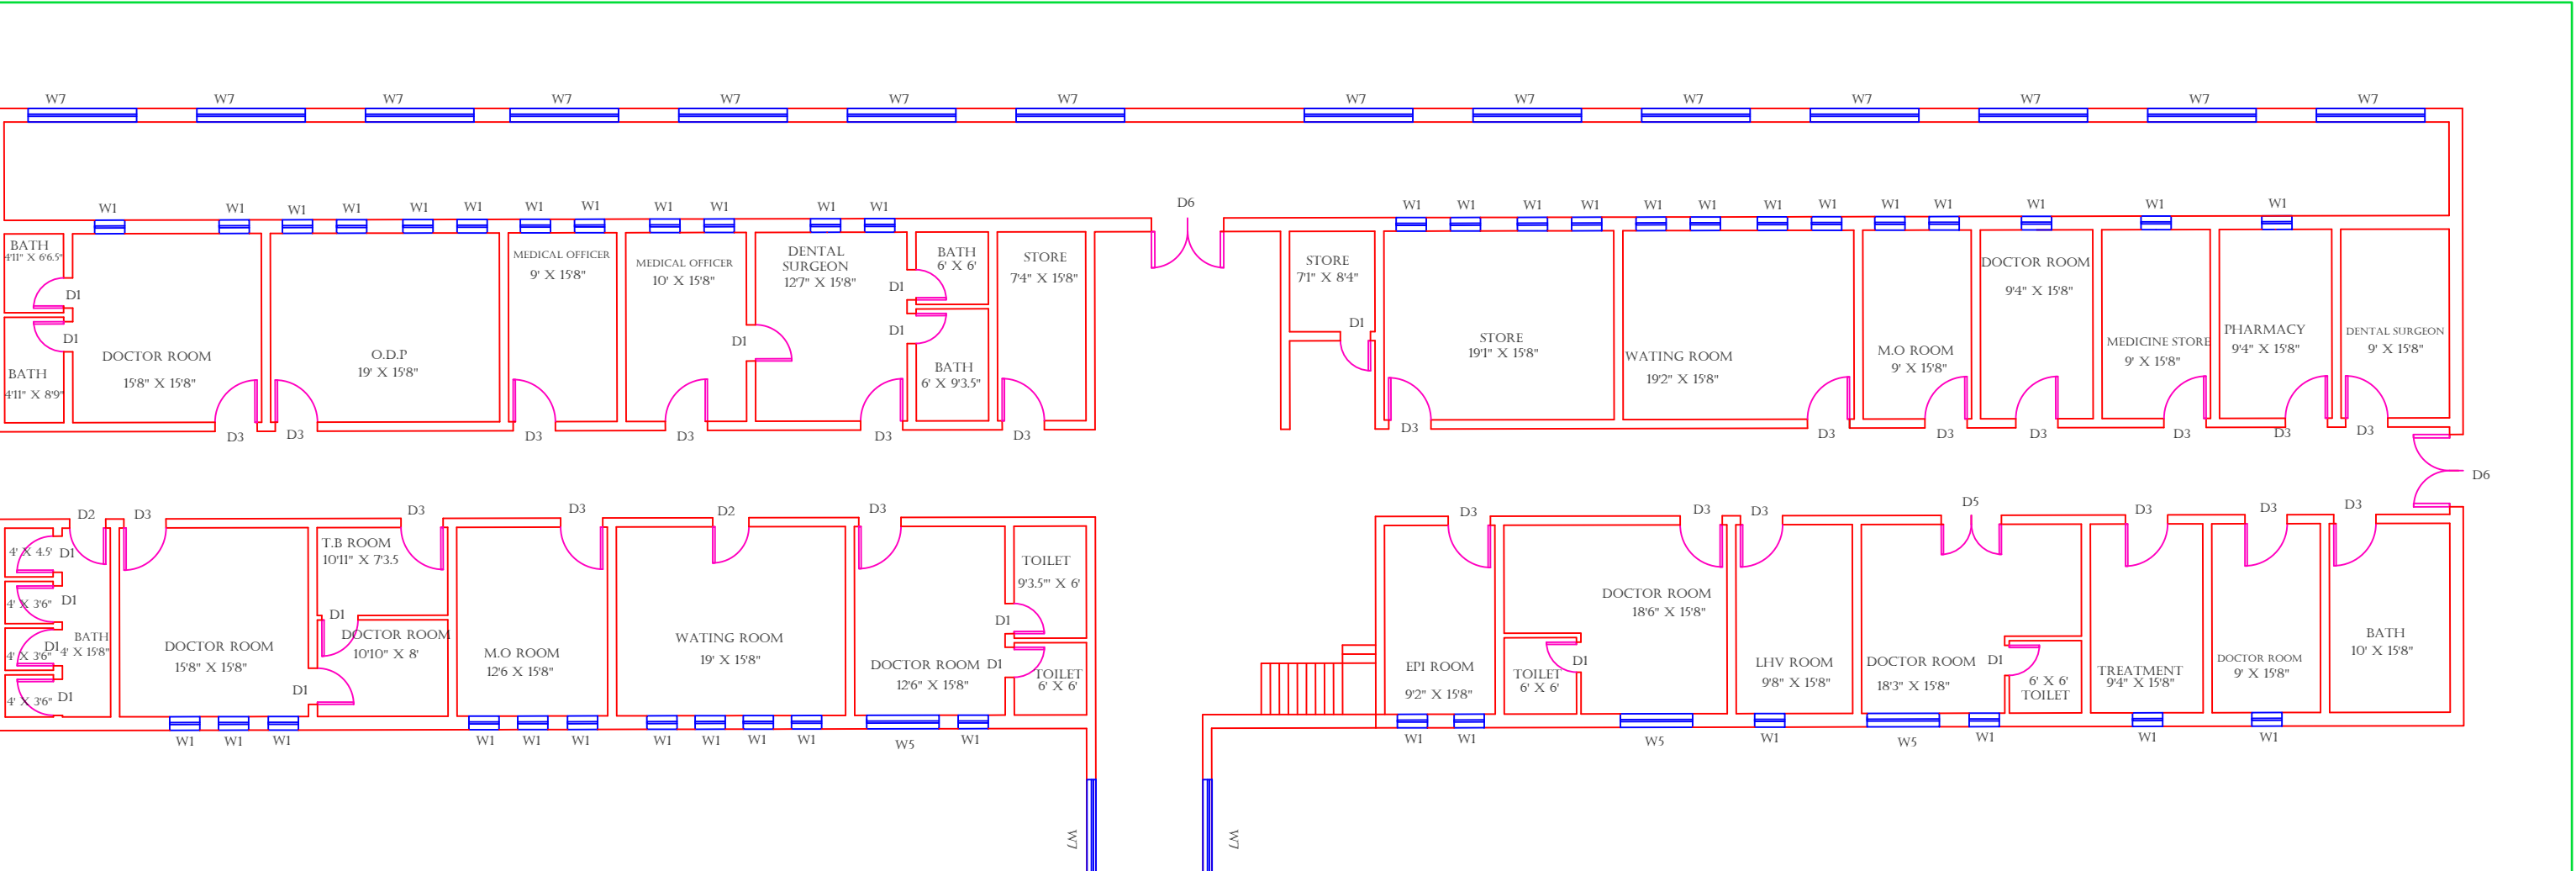

PART 2

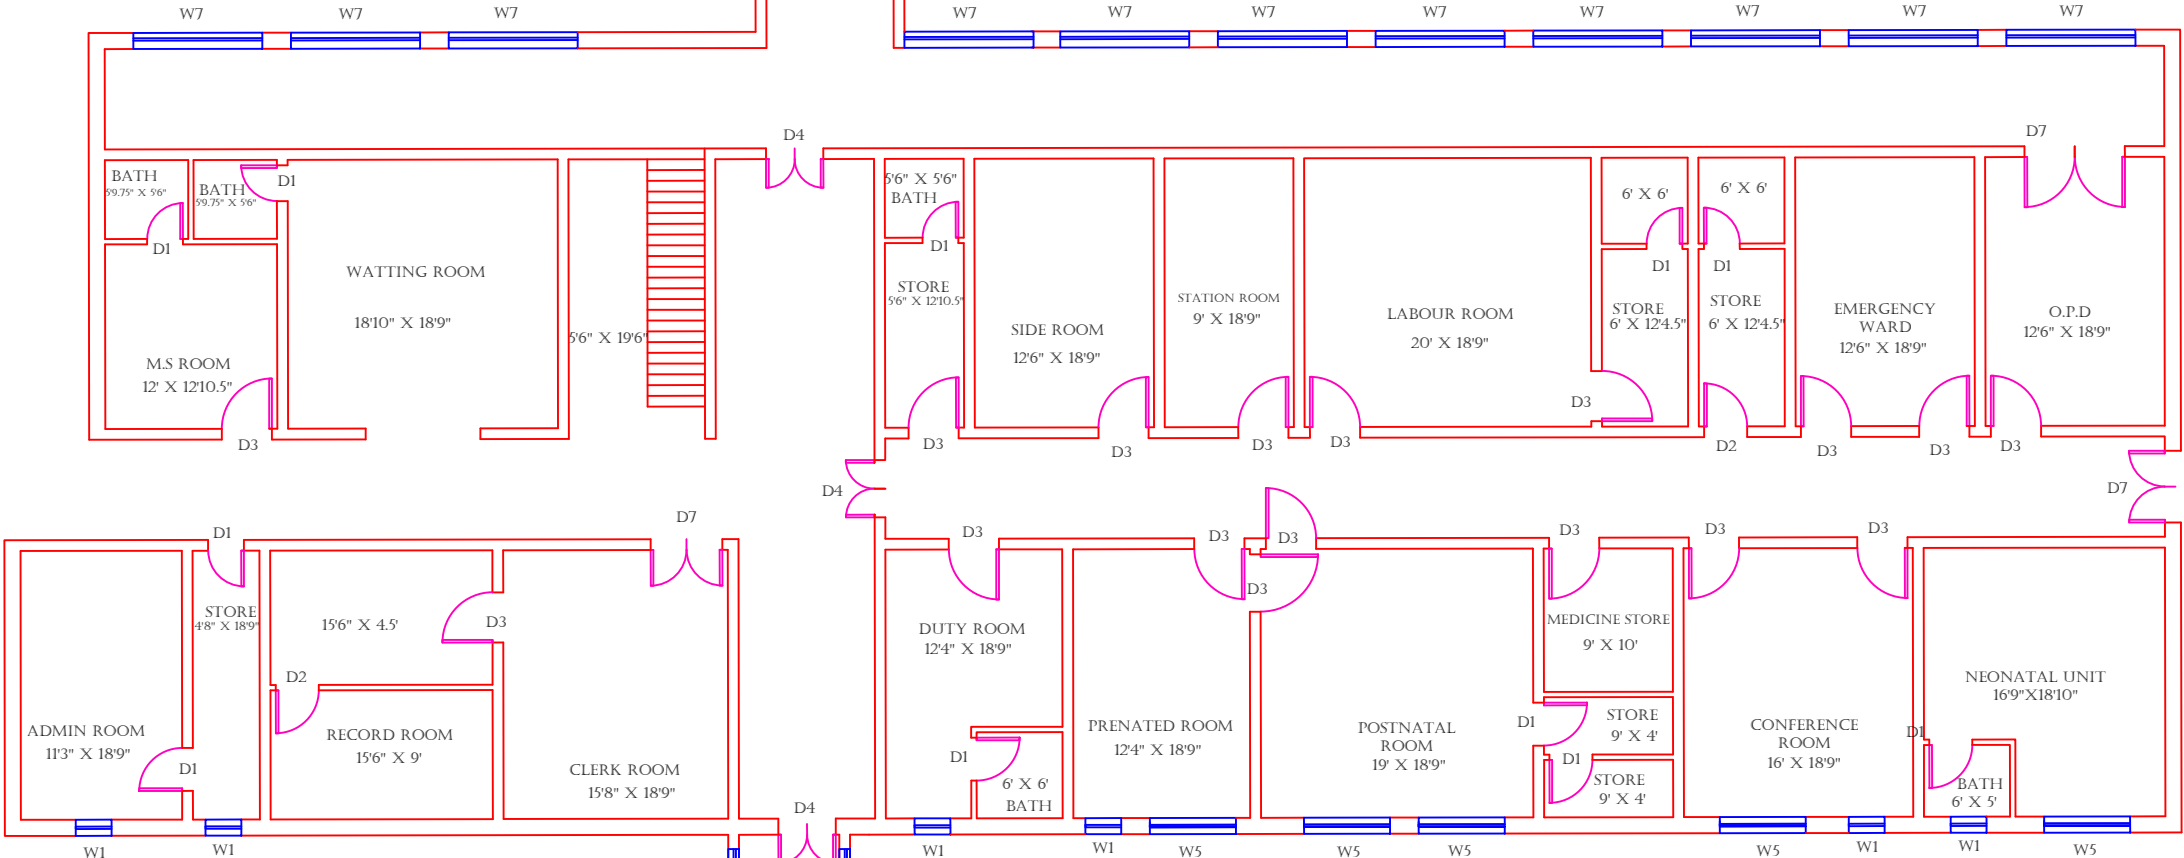

PART 3

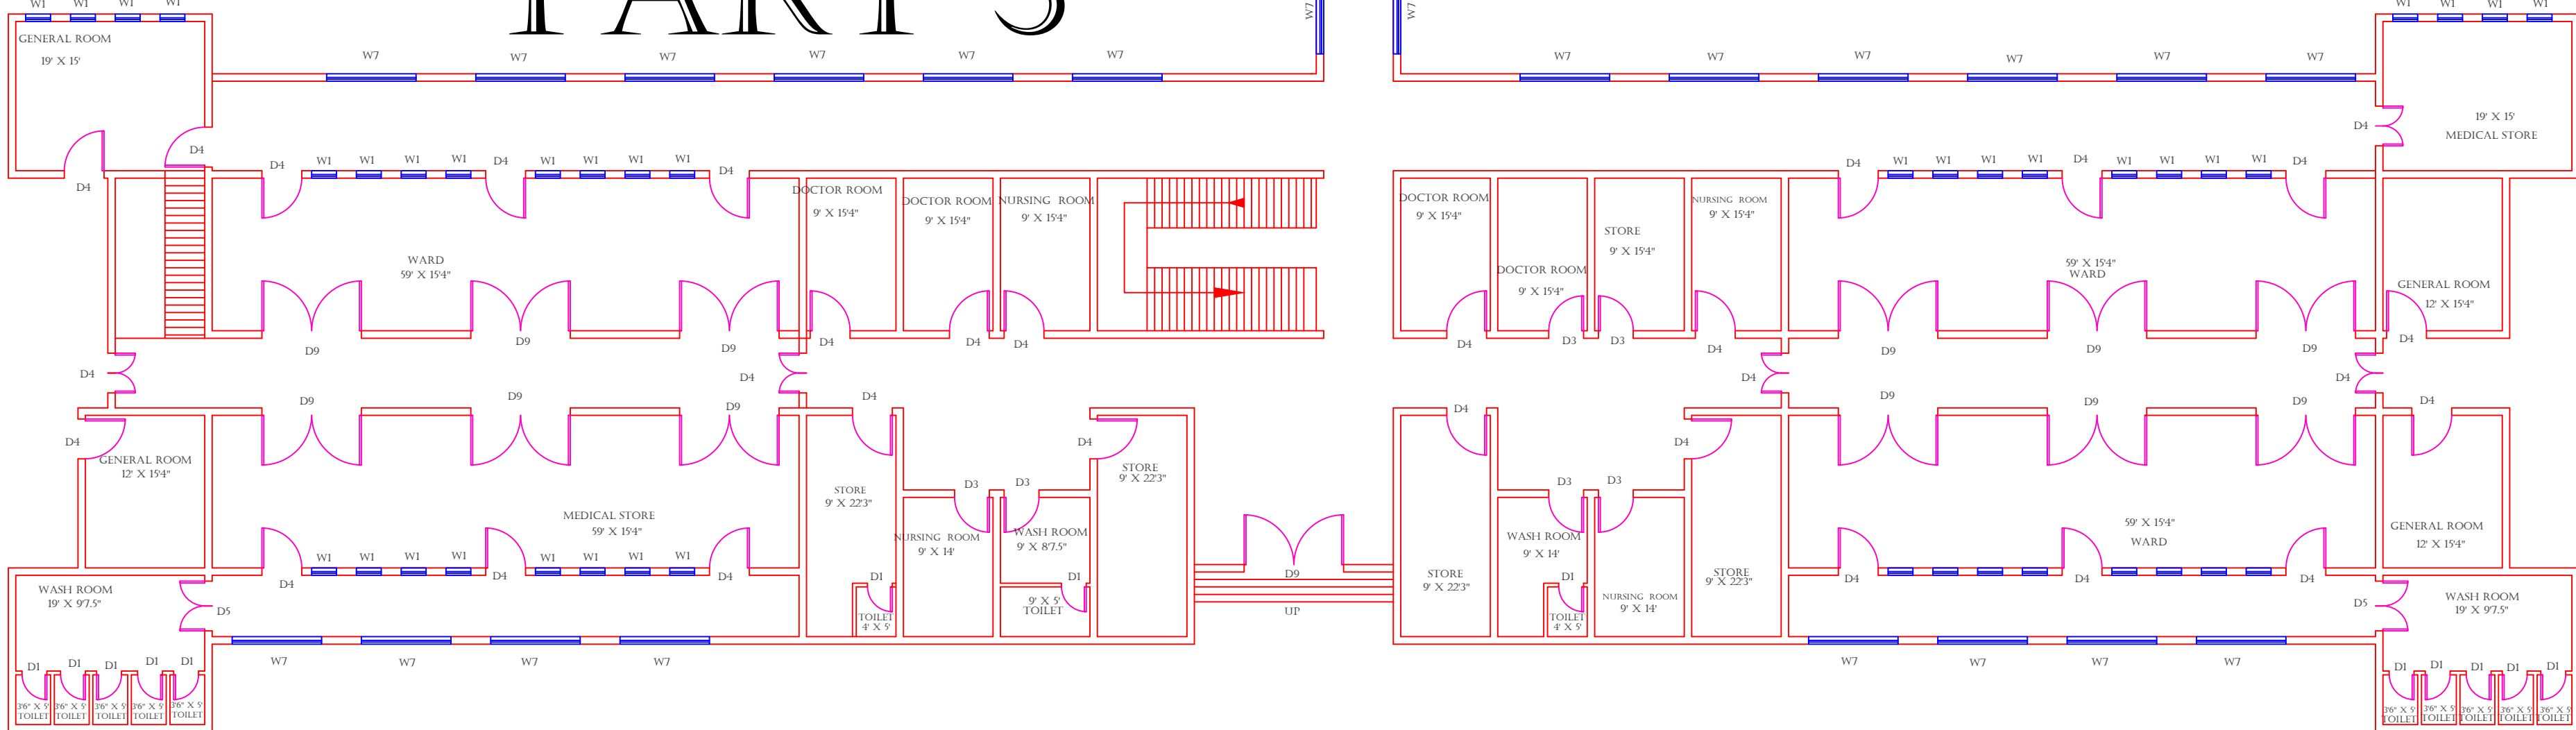

MAIN BUILDING

Legends:

RESIDENTIAL AREA	
ROAD	
WALL	
POWER LINE	
OHT	
TREE	
MANHOLE	
TUBE WELL	
LIGHT POLE	
LAWNS	
EARTHEN AREAS	
ASPHALTS ROADS	
TOUGH PAVERS	
P.C.C /PLINTH PROTECTION	
BOUNDARY WALL	
TAP	
HAND PUMP	
BRICK PAVERS	
AIR CONDITIONER	
TUBE LIGHT	
FAN	
ROOF LIGHT	
BULB	

AREA	
AREA WITHIN BOUNDARY WALL	255225.47 SFT
AREA OF CLINICAL BLOCK	146477.89 SFT
PLINTH AREA OF BLOCK	89148.993 SFT

OPENING SCHEDULE OF DOORS AND WINDOWS					
DOORS	WIDTH	HEIGHT	WINDOWS	WIDTH	HEIGHT
D1	2'-6"	7'-0"	W1	2'-6"	2'-6"
D2	3'-0"	7'-0"	W2	3'-0"	3'-0"
D3	3'-6"	7'-0"	W3	4'-0"	4'-0"
D4	4'-0"	7'-0"	W4	5'-0"	5'-0"
D5	5'-0"	7'-0"	W5	6'-0"	6'-0"
D6	6'-0"	7'-0"	W6	8'-0"	8'-0"
D7	7'-0"	7'-0"	W7	9'-0"	9'-0"
D8	8'-0"	7'-0"	V1		
D9			V2		

Client:

GOVERNMENT OF THE PUNJAB
PRIMARY & SECONDARY
HEALTHCARE DEPARTMENT

Project:

CAD MAPPING OF TEHSIL
HEAD QUARTER HOSPITALS,
PUNJAB

Consultant:

SKAFS CONSULTANT (Pvt.) Limited
ENGINEERING AND ENVIRONMENT CONSULTANT

Drawing Title:

THQ GUJARKHAN
HOSPITAL MAIN BUILDING
CLINICAL BLOCK PLAN

Authorized By:

SKAFS

Reviewed By:

Co-Team Leader

Scale:

1:300

Prepared By:

CAD TEAMS

Date:

FEB, 2017

Drawing No.

SKAFS/GUJARKHAN/08

CLINICAL BLOCK OF THQ HOSPITAL GUJAR KHAN

GROUND FLOOR (PART 1)

Legends:

RESIDENTIAL AREA	
ROAD	
WALL	
POWER LINE	
OHT	
TREE	
MANHOLE	
TUBE WELL	
LIGHT POLE	
LAWNS	
EARTHEN AREAS	
ASPHALTS ROADS	
TOUGH PAVERS	
P.C.C /PLINTH PROTECTION	
BOUNDARY WALL	
TAP	
HAND PUMP	
BRICK PAVERS	
AIR CONDITIONER	
TUBE LIGHT	
FAN	
ROOF LIGHT	
BULB	

AREA	
AREA WITHIN BOUNDARY WALL	255225.47 SFT
AREA OF CLINICAL BLOCK	146477.89 SFT
PLINTH AREA OF BLOCK	89148.993 SFT

OPENING SCHEDULE OF DOORS AND WINDOWS					
DOORS	WIDTH	HEIGHT	WINDOWS	WIDTH	HEIGHT
D1	2'-6"	7'-0"	W1	2'-6"	2'-6"
D2	3'-0"	7'-0"	W2	3'-0"	3'-0"
D3	3'-6"	7'-0"	W3	4'-0"	4'-0"
D4	4'-0"	7'-0"	W4	5'-0"	5'-0"
D5	5'-0"	7'-0"	W5	6'-0"	6'-0"
D6	6'-0"	7'-0"	W6	8'-0"	8'-0"
D7	7'-0"	7'-0"	W7	9'-0"	9'-0"
D8	8'-0"	7'-0"	V1		
D9			V2		

Client:



GOVERNMENT OF THE PUNJAB
PRIMARY & SECONDARY
HEALTHCARE DEPARTMENT

Project:

CAD MAPPING OF TEHSIL
HEAD QUARTER HOSPITALS,
PUNJAB

Consultant:




SKAFS CONSULTANT (Pvt.) Limited
ENGINEERING AND ENVIRONMENT CONSULTANT

Drawing Title:


THQ GUJARKHAN
HOSPITAL CLINICAL BLOCK
PART 1

Authorized By: SKAFS	Reviewed By Co-Team Leader	Scale:
Prepared By: CAD TEAMS	Date: FEB, 2017	
Drawing No.		SKAFS/GUJARKHAN/09

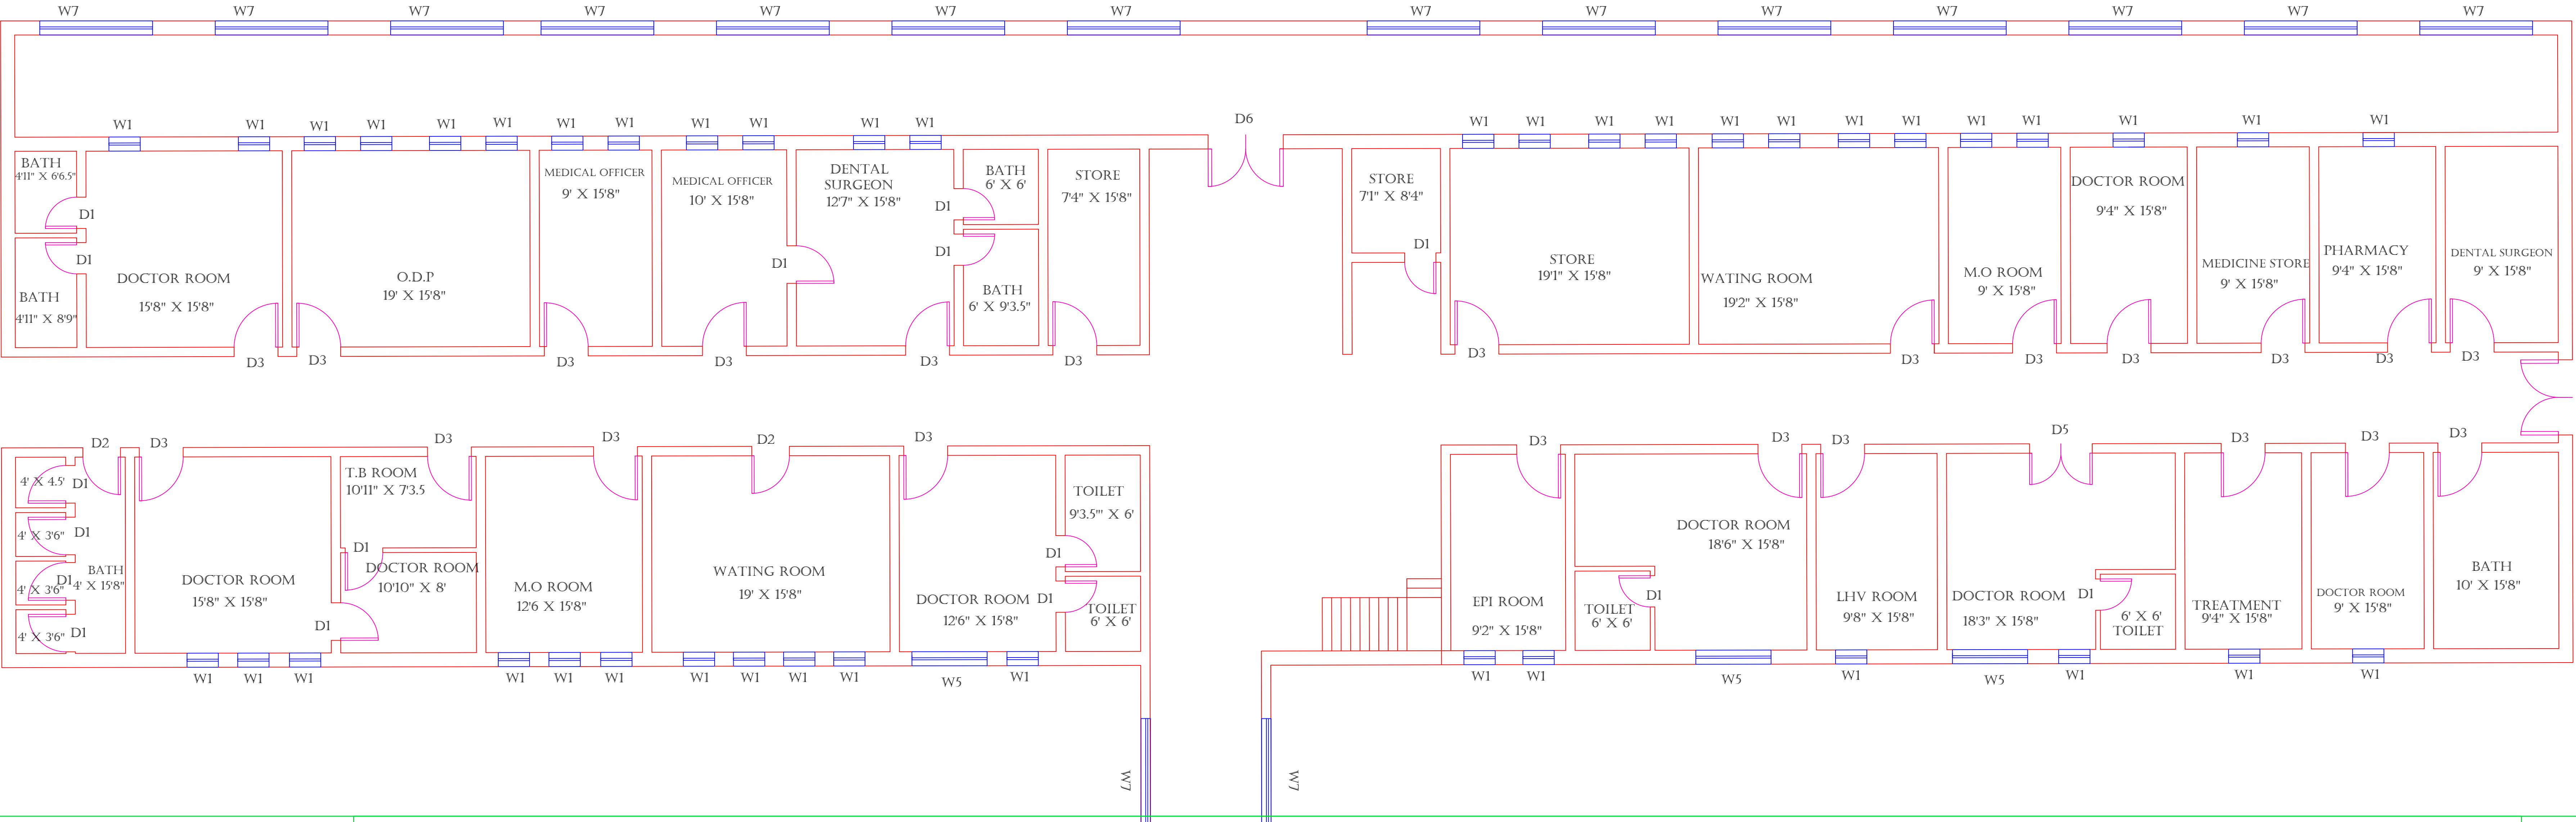

CLINICAL BLOCK OF THQ HOSPITAL GUJAR KHAN

GROUND FLOOR (PART 2)

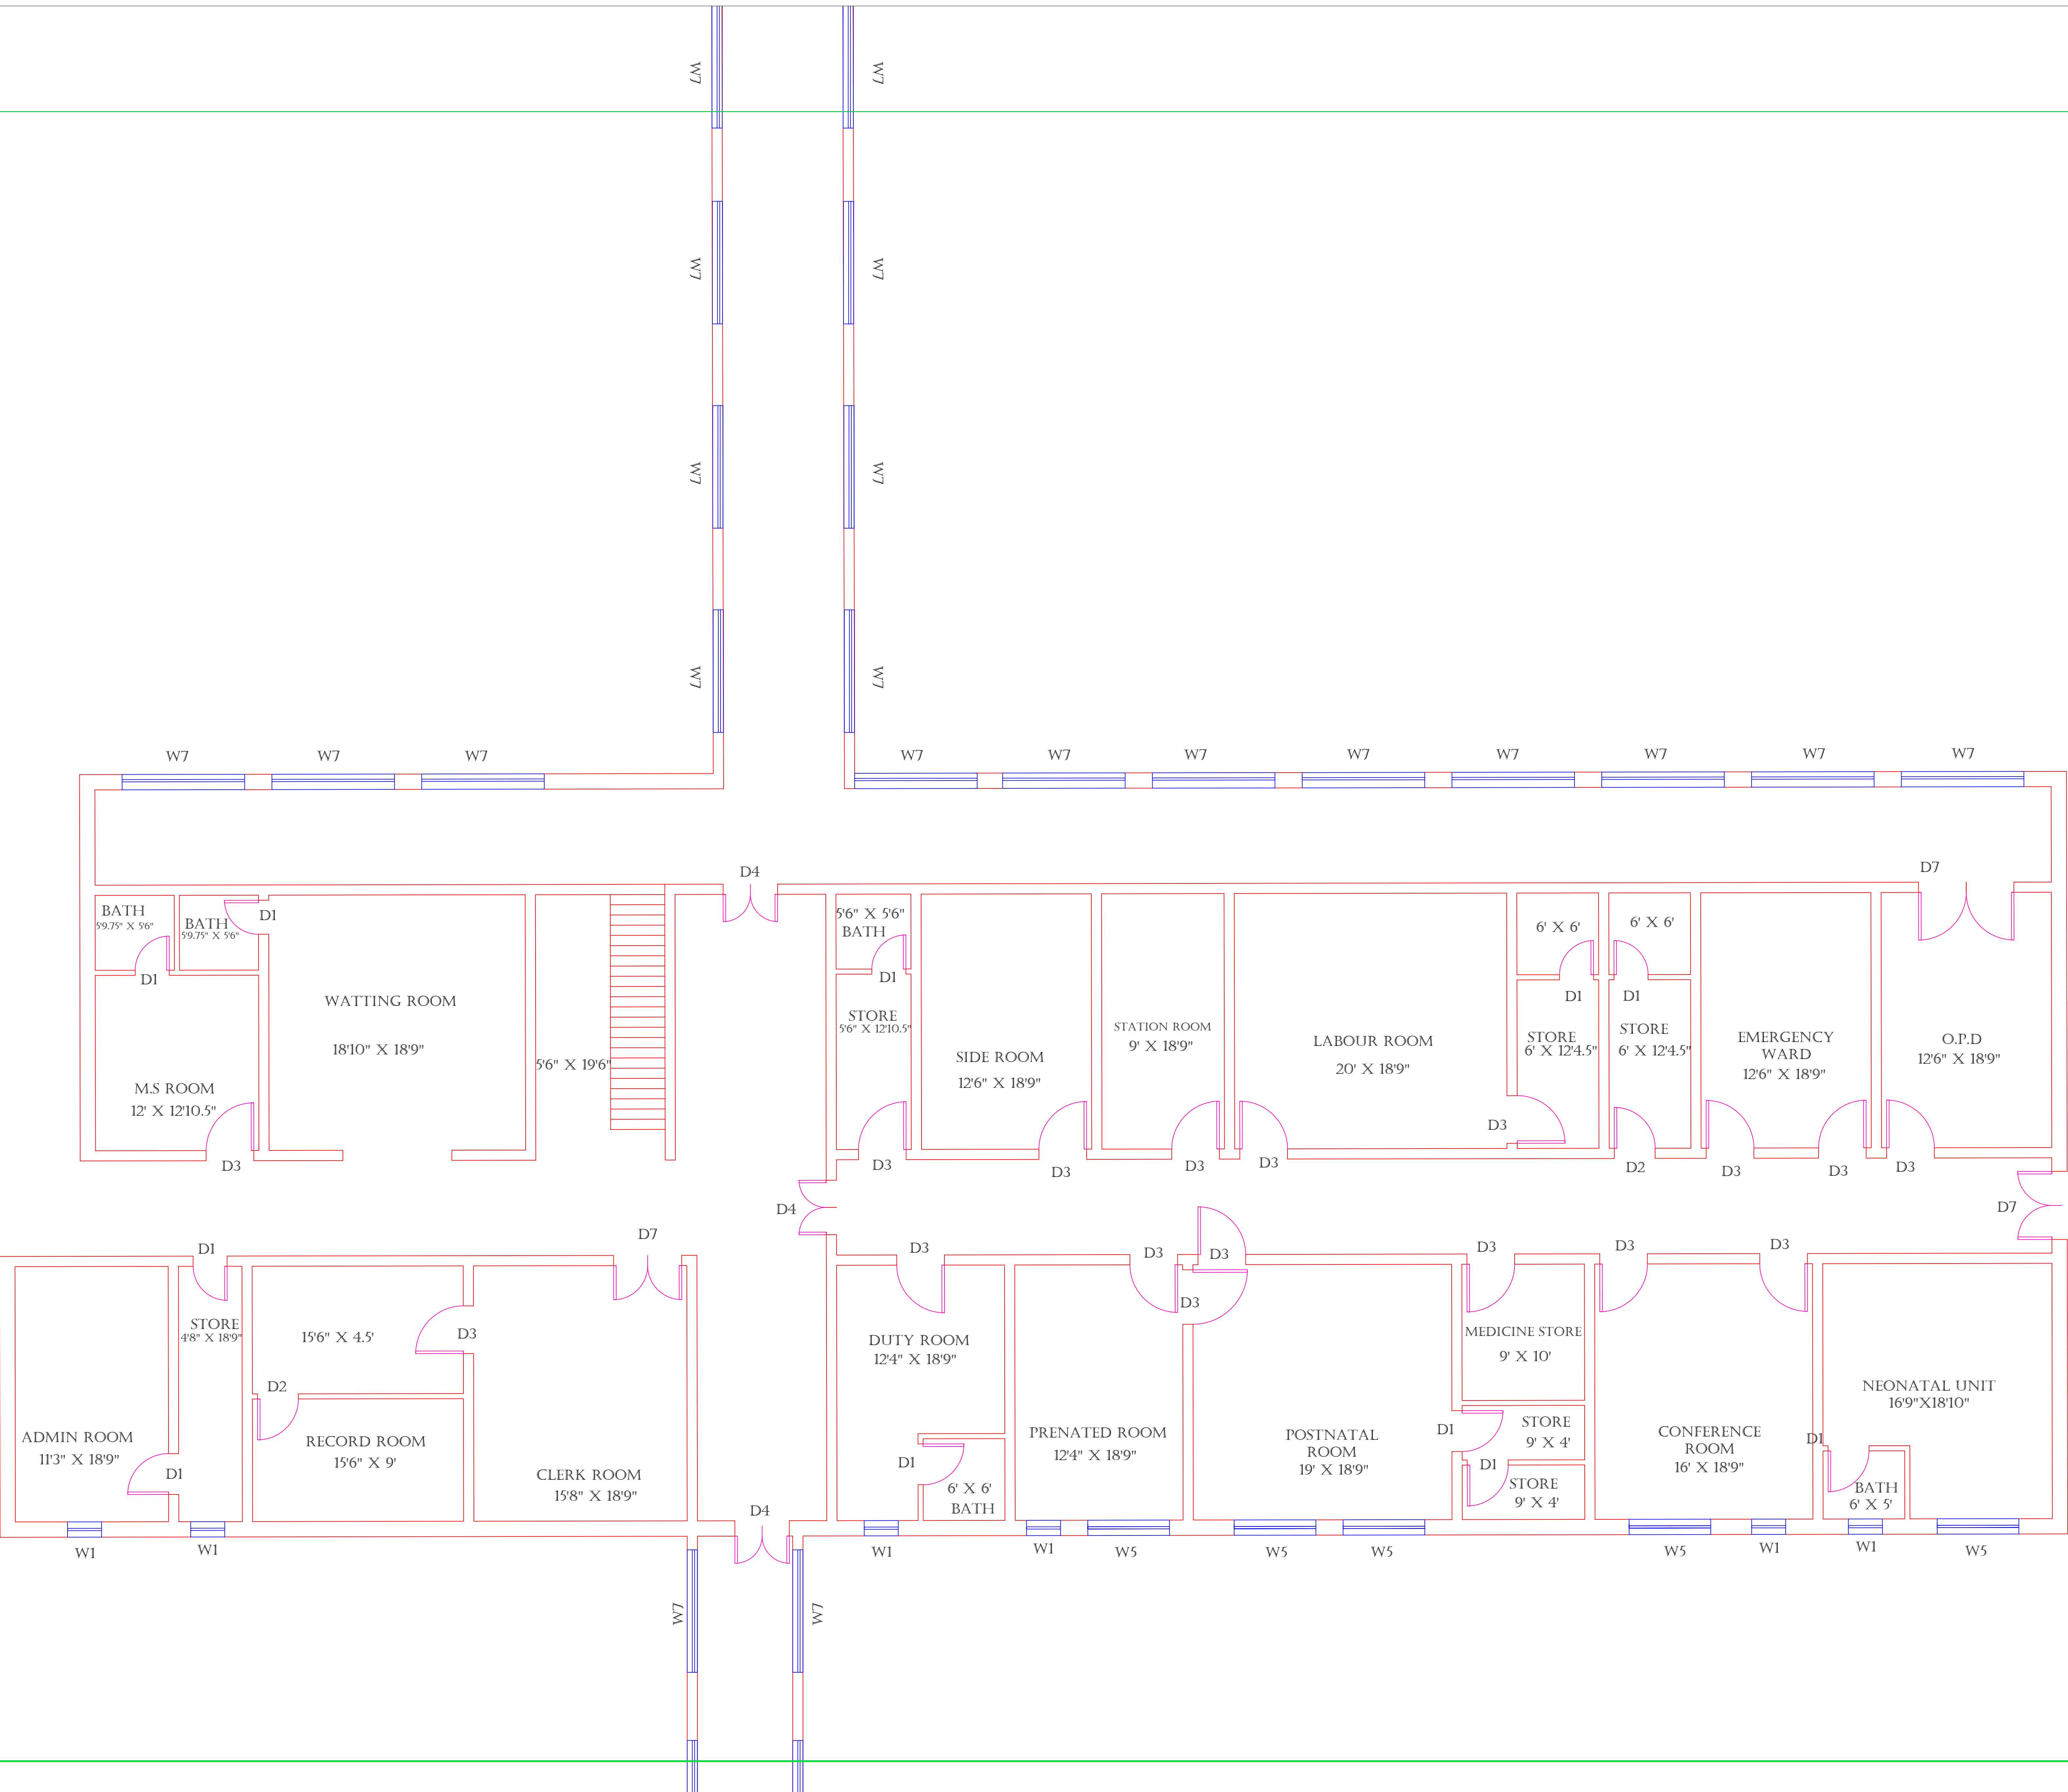

Legends:

RESIDENTIAL AREA	
ROAD	
WALL	
POWER LINE	
OHT	
TREE	
MANHOLE	
TUBE WELL	
LIGHT POLE	
LAWNS	
EARTHEN AREAS	
ASPHALTS ROADS	
TOUGH PAVERS	
P.C.C /PLINTH PROTECTION	
BOUNDARY WALL	
TAP	
HAND PUMP	
BRICK PAVERS	
AIR CONDITIONER	
TUBE LIGHT	
FAN	
ROOF LIGHT	
BULB	

AREA	
AREA WITHIN BOUNDARY WALL	255225.47 SFT
AREA OF CLINICAL BLOCK	146477.89 SFT
PLINTH AREA OF BLOCK	89148.993 SFT

OPENING SCHEDULE OF DOORS AND WINDOWS					
DOORS	WIDTH	HEIGHT	WINDOWS	WIDTH	HEIGHT
D1	2'-6"	7'-0"	W1	2'-6"	2'-6"
D2	3'-0"	7'-0"	W2	3'-0"	3'-0"
D3	3'-6"	7'-0"	W3	4'-0"	4'-0"
D4	4'-0"	7'-0"	W4	5'-0"	5'-0"
D5	5'-0"	7'-0"	W5	6'-0"	6'-0"
D6	6'-0"	7'-0"	W6	8'-0"	8'-0"
D7	7'-0"	7'-0"	W7	9'-0"	9'-0"
D8	8'-0"	7'-0"	V1		
D9			V2		

Client:



**GOVERNMENT OF THE PUNJAB
PRIMARY & SECONDARY
HEALTHCARE DEPARTMENT**

Project:

**CAD MAPPING OF TEHSIL
HEAD QUARTER HOSPITALS,
PUNJAB**

Consultant:



SKAFS CONSULTANT (Pvt.) Limited
ENGINEERING AND ENVIRONMENT CONSULTANT


Drawing Title:

**THQ GUJARKHAN
HOSPITAL CLINICAL BLOCK
PART 2**

Authorized By: SKAFS	Reviewed By Co-Team Leader	Scale:
Prepared By: CAD TEAMS	Date: FEB, 2017	
Drawing No.		SKAFS/GUJARKHAN/10

CLINICAL BLOCK OF THQ HOSPITAL GUJAR KHAN

GROUND FLOOR (PART 3)

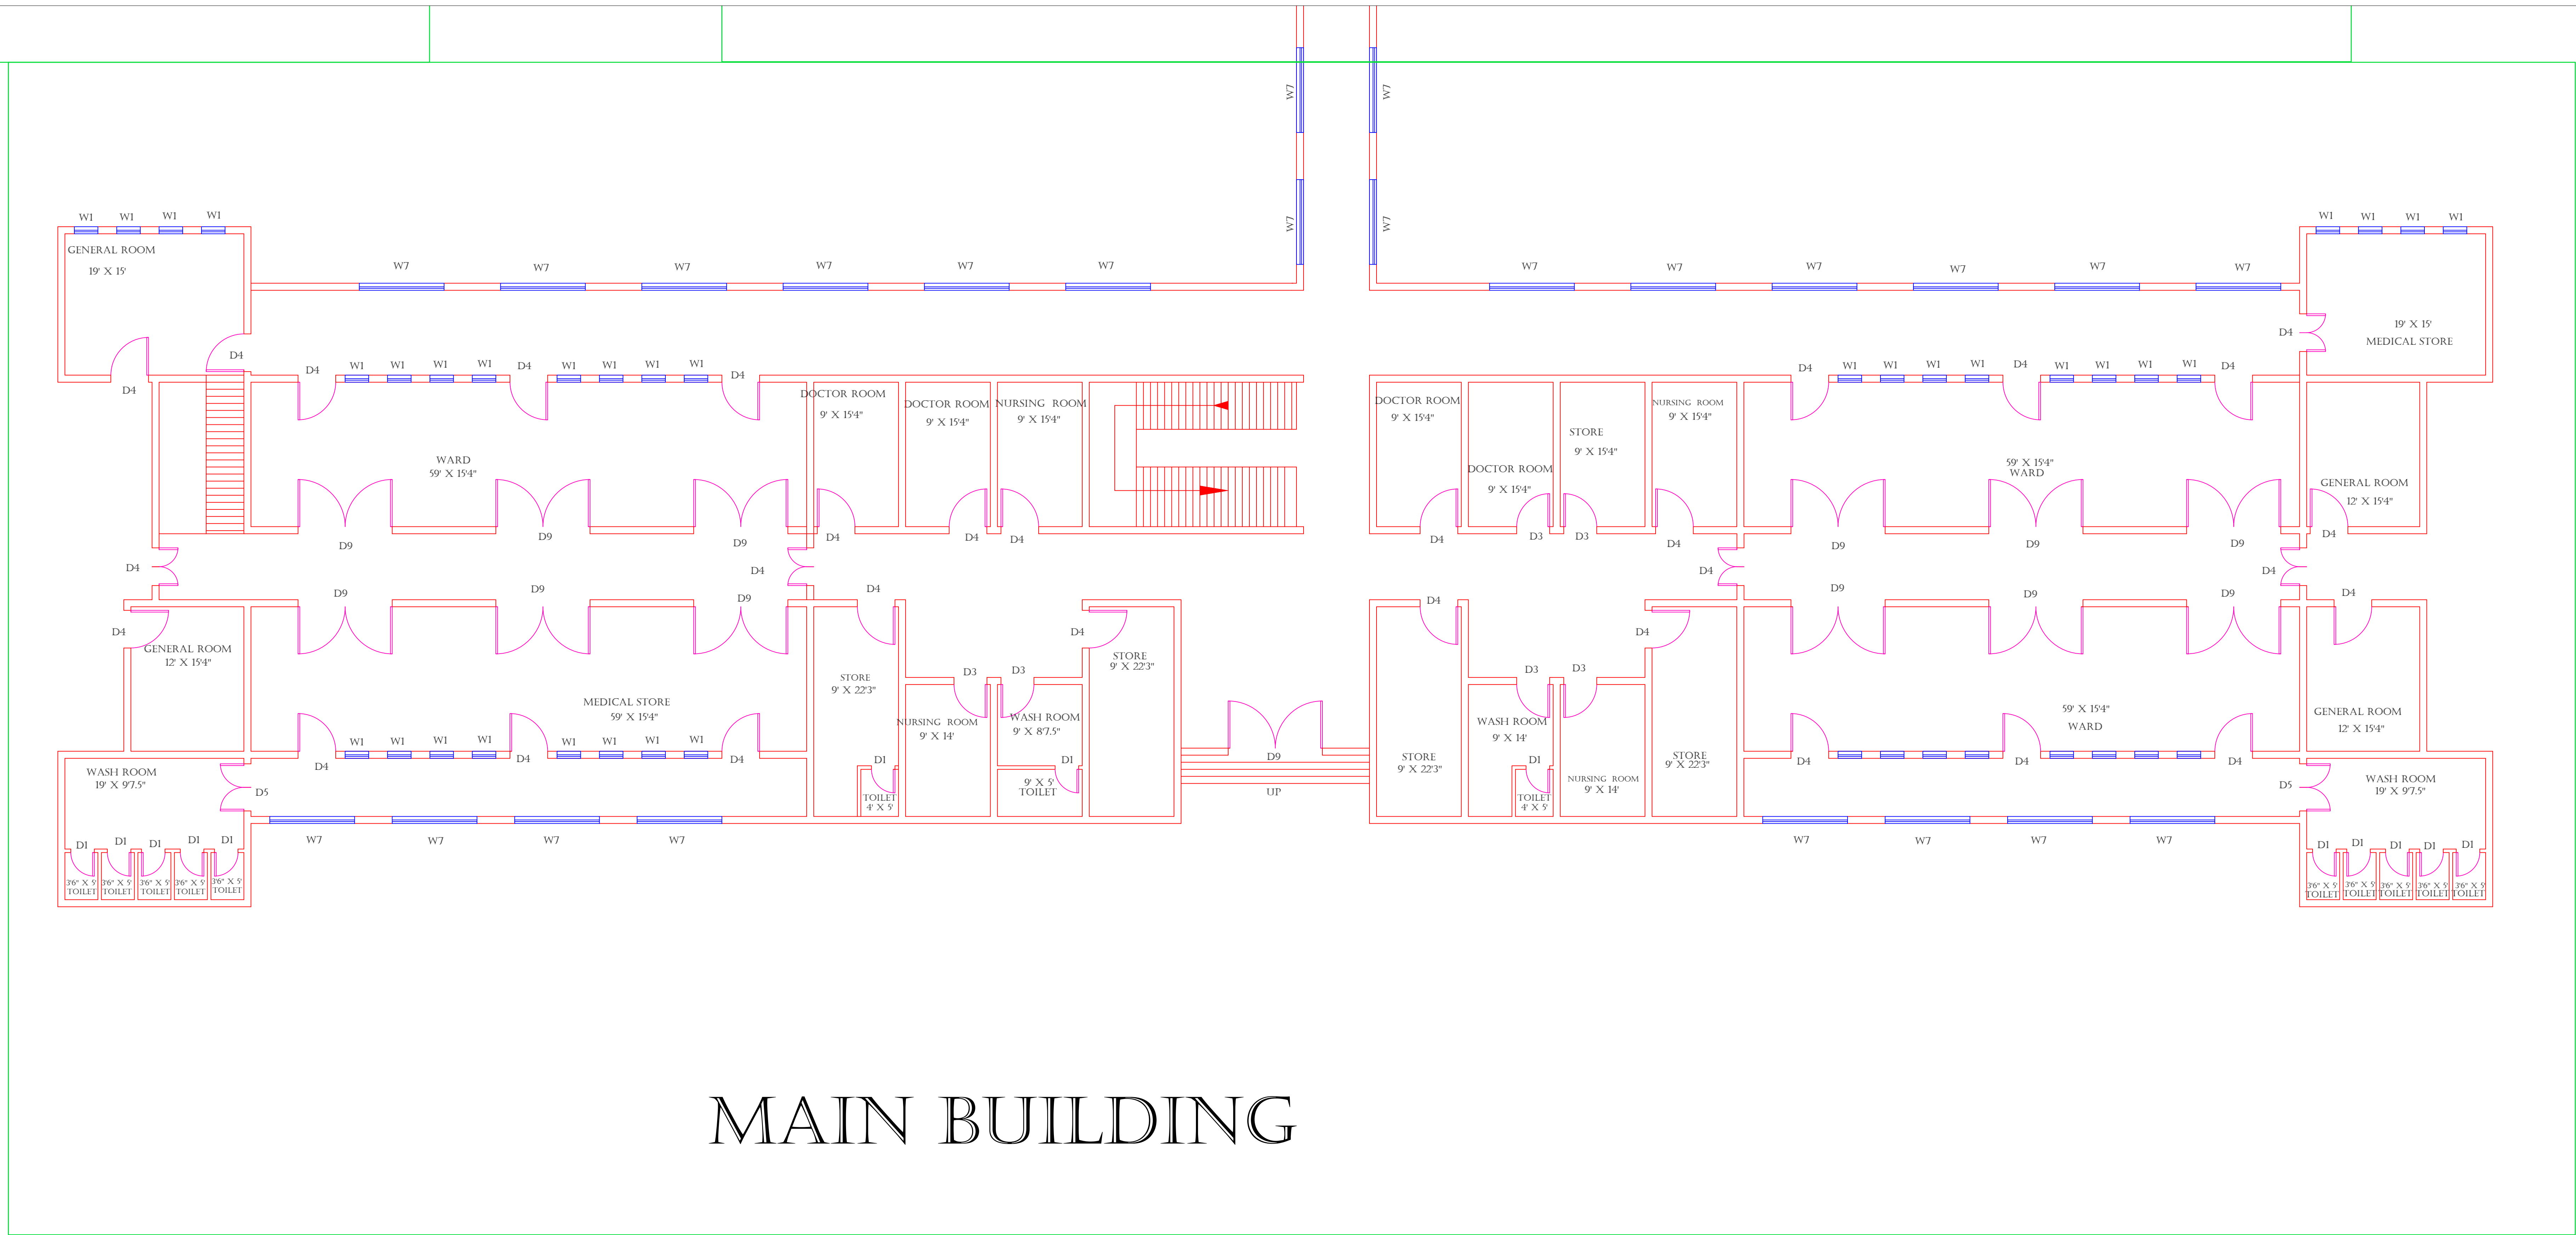

Legends:

RESIDENTIAL AREA	
ROAD	
WALL	
POWER LINE	
OHT	
TREE	
MANHOLE	
TUBE WELL	
LIGHT POLE	
LAWNS	
EARTHEN AREAS	
ASPHALTS ROADS	
TOUGH PAVERS	
P.C.C /PLINTH PROTECTION	
BOUNDARY WALL	
TAP	
HAND PUMP	
BRICK PAVERS	
AIR CONDITIONER	
TUBE LIGHT	
FAN	
ROOF LIGHT	
BULB	

AREA	
AREA WITHIN BOUNDARY WALL	255225.47 SFT
AREA OF CLINICAL BLOCK	146477.89 SFT
PLINTH AREA OF BLOCK	89148.993 SFT

OPENING SCHEDULE OF DOORS AND WINDOWS					
DOORS	WIDTH	HEIGHT	WINDOWS	WIDTH	HEIGHT
D1	2'-6"	7'-0"	W1	2'-6"	2'-6"
D2	3'-0"	7'-0"	W2	3'-0"	3'-0"
D3	3'-6"	7'-0"	W3	4'-0"	4'-0"
D4	4'-0"	7'-0"	W4	5'-0"	5'-0"
D5	5'-0"	7'-0"	W5	6'-0"	6'-0"
D6	6'-0"	7'-0"	W6	8'-0"	8'-0"
D7	7'-0"	7'-0"	W7	9'-0"	9'-0"
D8	8'-0"	7'-0"	V1		
D9			V2		

Client:



GOVERNMENT OF THE PUNJAB
PRIMARY & SECONDARY
HEALTHCARE DEPARTMENT

Project:

CAD MAPPING OF TEHSIL
HEAD QUARTER HOSPITALS,
PUNJAB

Consultant:



SKAFS CONSULTANT (Pvt.) Limited
ENGINEERING AND ENVIRONMENT CONSULTANT


Drawing Title:

THQ GUJARKHAN
HOSPITAL CLINICAL BLOCK
PART 3

Authorized By: SKAFS	Reviewed By Co-Team Leader	Scale:
Prepared By: CAD TEAMS	Date: FEB, 2017	
Drawing No. SKAFS/GUJARKHAN/11		

CLINICAL BLOCK OF THQ HOSPITAL GUJAR KHAN

GROUND FLOOR (PART 4)

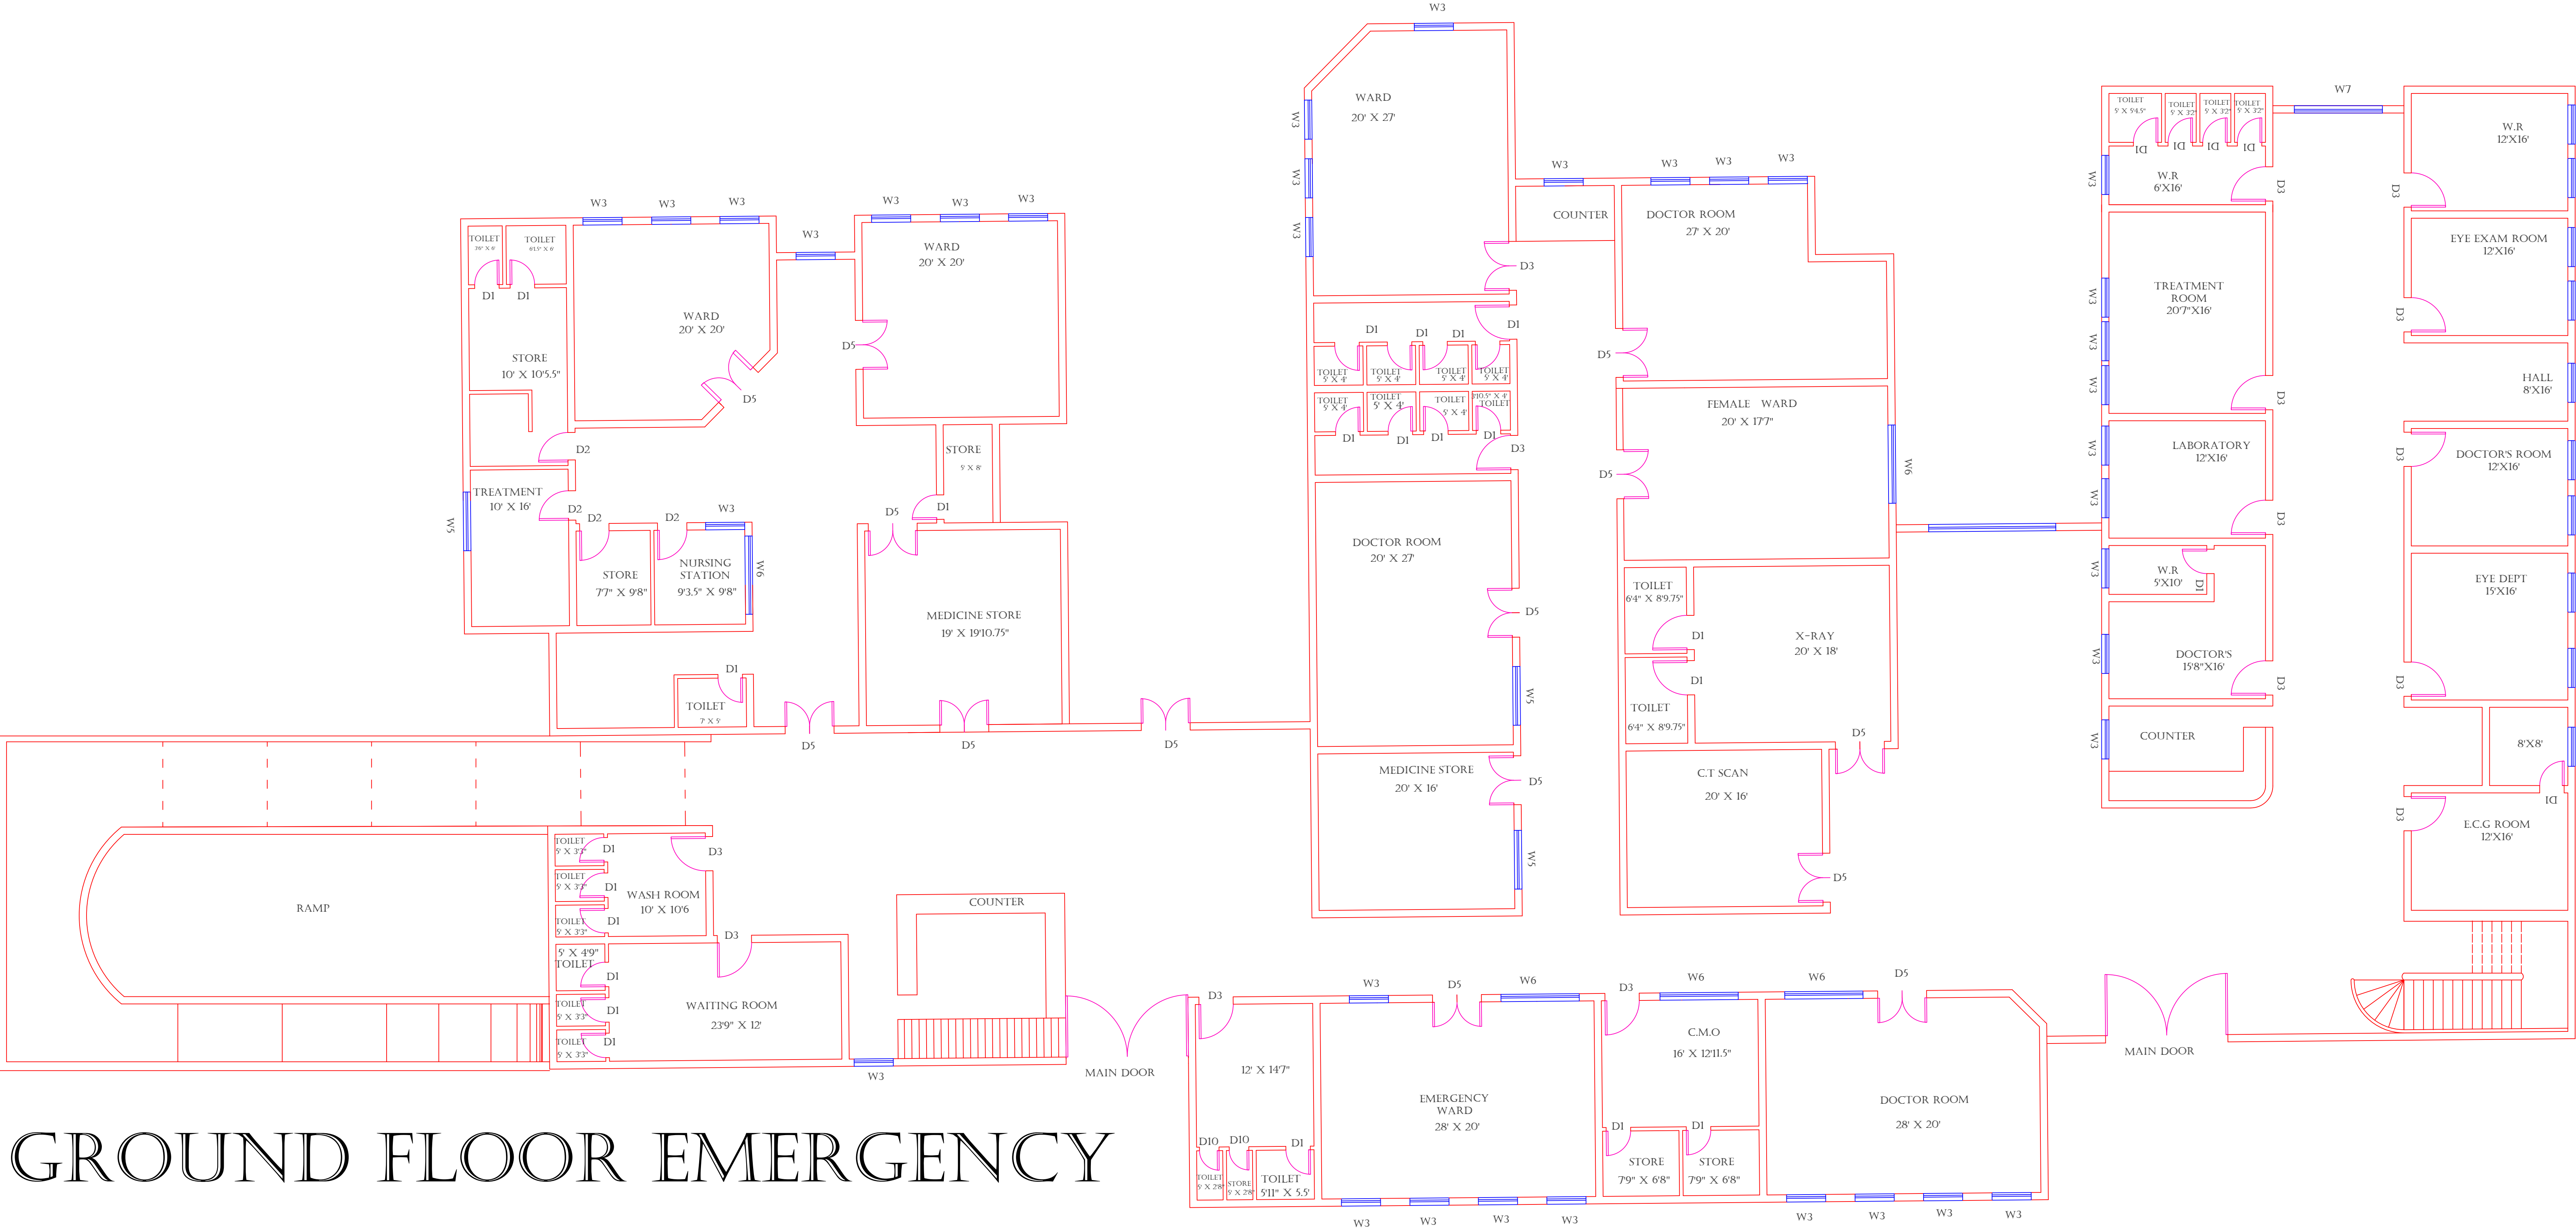

GROUND FLOOR EMERGENCY

Legends:

RESIDENTIAL AREA	
ROAD	
WALL	
POWER LINE	
OHT	
TREE	
MANHOLE	
TUBE WELL	
LIGHT POLE	
LAWNS	
EARTHEN AREAS	
ASPHALTS ROADS	
TOUGH PAVERS	
P.C.C /PLINTH PROTECTION	
BOUNDARY WALL	
TAP	
HAND PUMP	
BRICK PAVERS	
AIR CONDITIONER	
TUBE LIGHT	
FAN	
ROOF LIGHT	
BULB	

AREA	
AREA WITHIN BOUNDARY WALL	255225.47 SFT
AREA OF CLINICAL BLOCK	146477.89 SFT
PLINTH AREA OF BLOCK	89148.993 SFT

OPENING SCHEDULE OF DOORS AND WINDOWS					
DOORS	WIDTH	HEIGHT	WINDOWS	WIDTH	HEIGHT
D1	2'-6"	7'-0"	W1	2'-6"	2'-6"
D2	3'-0"	7'-0"	W2	3'-0"	3'-0"
D3	3'-6"	7'-0"	W3	4'-0"	4'-0"
D4	4'-0"	7'-0"	W4	5'-0"	5'-0"
D5	5'-0"	7'-0"	W5	6'-0"	6'-0"
D6	6'-0"	7'-0"	W6	8'-0"	8'-0"
D7	7'-0"	7'-0"	W7	9'-0"	9'-0"
D8	8'-0"	7'-0"	V1		
D9			V2		

Client:

GOVERNMENT OF THE PUNJAB
PRIMARY & SECONDARY
HEALTHCARE DEPARTMENT

Project:

CAD MAPPING OF TEHSIL
HEAD QUARTER HOSPITALS,
PUNJAB

Consultant:

SKAFS CONSULTANT (Pvt.) Limited
ENGINEERING AND ENVIRONMENT CONSULTANT


Drawing Title:

THQ GUJARKHAN
HOSPITAL CLINICAL BLOCK
PART 4

Authorized By: SKAFS	Reviewed By Co-Team Leader	Scale:
Prepared By: CAD TEAMS	Date: FEB, 2017	
Drawing No.		SKAFS/GUJARKHAN/12

CLINICAL BLOCK OF THQ HOSPITAL GUJAR KHAN

FIRST FLOOR (PART 1)

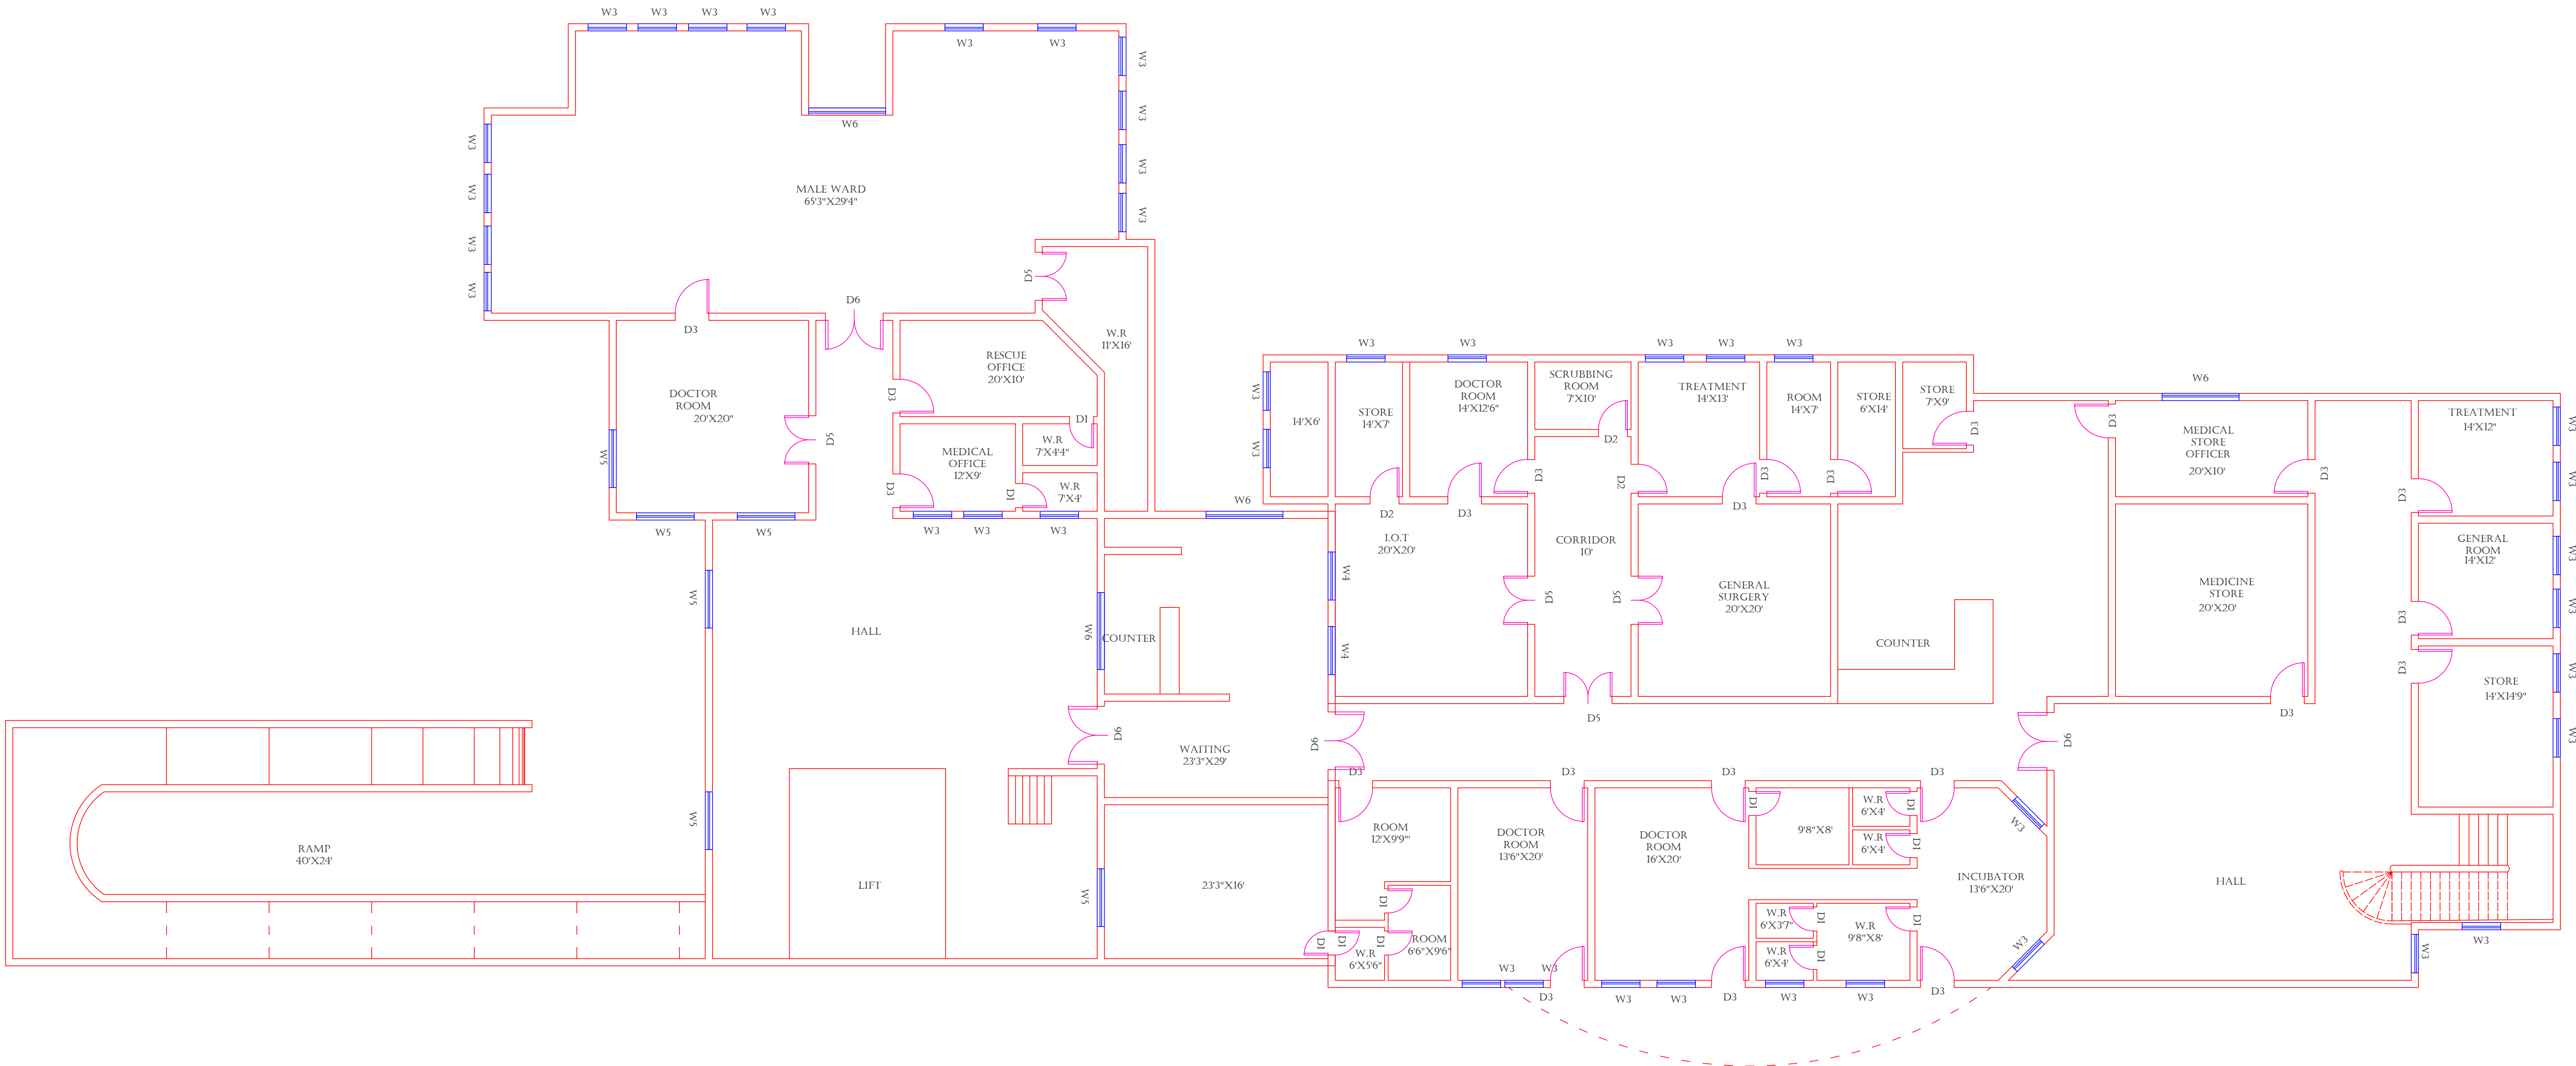

FIRST FLOOR EMERGENCY

Legends:

RESIDENTIAL AREA	
ROAD	
WALL	
POWER LINE	
OHT	
TREE	
MANHOLE	
TUBE WELL	
LIGHT POLE	
LAWNS	
EARTHEN AREAS	
ASPHALTS ROADS	
TOUGH PAVERS	
P.C.C /PLINTH PROTECTION	
BOUNDARY WALL	
TAP	
HAND PUMP	
BRICK PAVERS	
AIR CONDITIONER	
TUBE LIGHT	
FAN	
ROOF LIGHT	
BULB	

AREA	
AREA WITHIN BOUNDARY WALL	255225.47 SFT
AREA OF CLINICAL BLOCK	146477.89 SFT
PLINTH AREA OF BLOCK	89148.993 SFT

OPENING SCHEDULE OF DOORS AND WINDOWS					
DOORS	WIDTH	HEIGHT	WINDOWS	WIDTH	HEIGHT
D1	2'-6"	7'-0"	W1	2'-6"	2'-6"
D2	3'-0"	7'-0"	W2	3'-0"	3'-0"
D3	3'-6"	7'-0"	W3	4'-0"	4'-0"
D4	4'-0"	7'-0"	W4	5'-0"	5'-0"
D5	5'-0"	7'-0"	W5	6'-0"	6'-0"
D6	6'-0"	7'-0"	W6	8'-0"	8'-0"
D7	7'-0"	7'-0"	W7	9'-0"	9'-0"
D8	8'-0"	7'-0"	V1		
D9			V2		

Client:



GOVERNMENT OF THE PUNJAB
PRIMARY & SECONDARY
HEALTHCARE DEPARTMENT

Project:

CAD MAPPING OF TEHSIL
HEAD QUARTER HOSPITALS,
PUNJAB

Consultant:



SKAFS CONSULTANT (Pvt.) Limited
ENGINEERING AND ENVIRONMENT CONSULTANT


Drawing Title:

THQ GUJARKHAN
HOSPITAL CLINICAL BLOCK
PART 4


Authorized By: SKAFS	Reviewed By Co-Team Leader	Scale:
Prepared By: CAD TEAMS	Date: FEB, 2017	
Drawing No. SKAFS/GUJARKHAN/13		

ELECTRICAL LAYOUT PLAN OF THQ HOSPITAL GUJAR KHAN

GROUND FLOOR

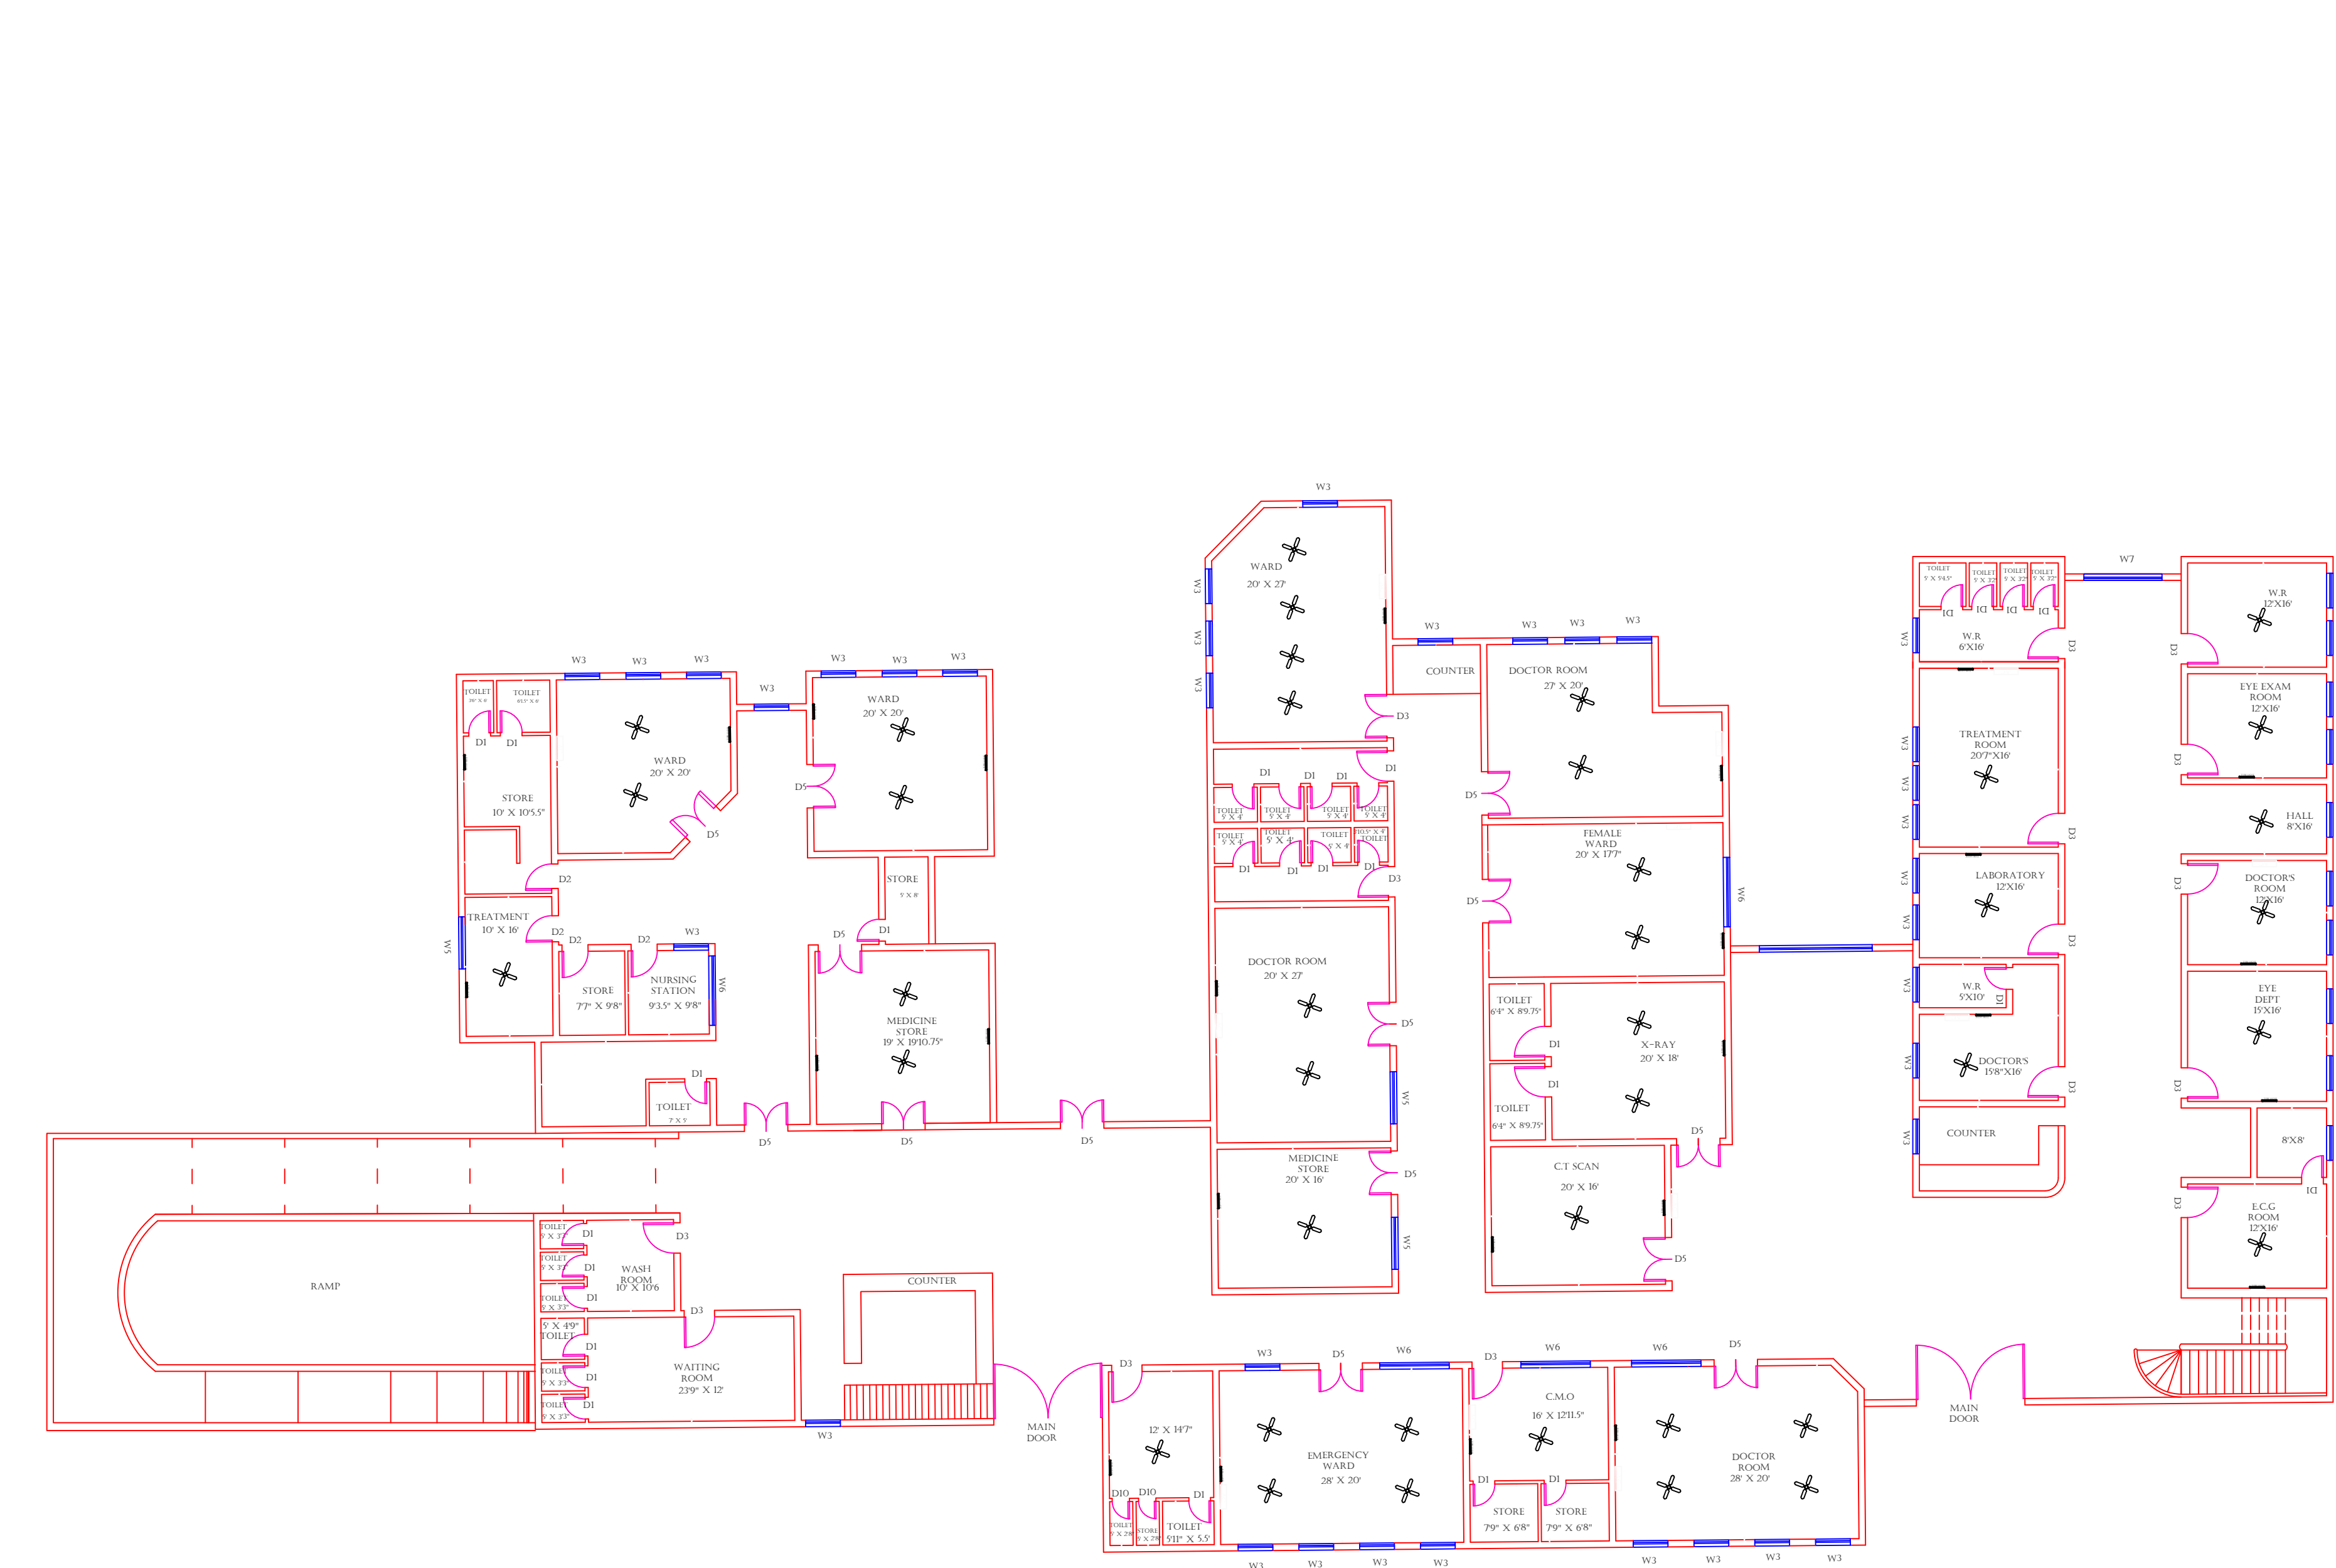

GROUND FLOOR EMERGENCY

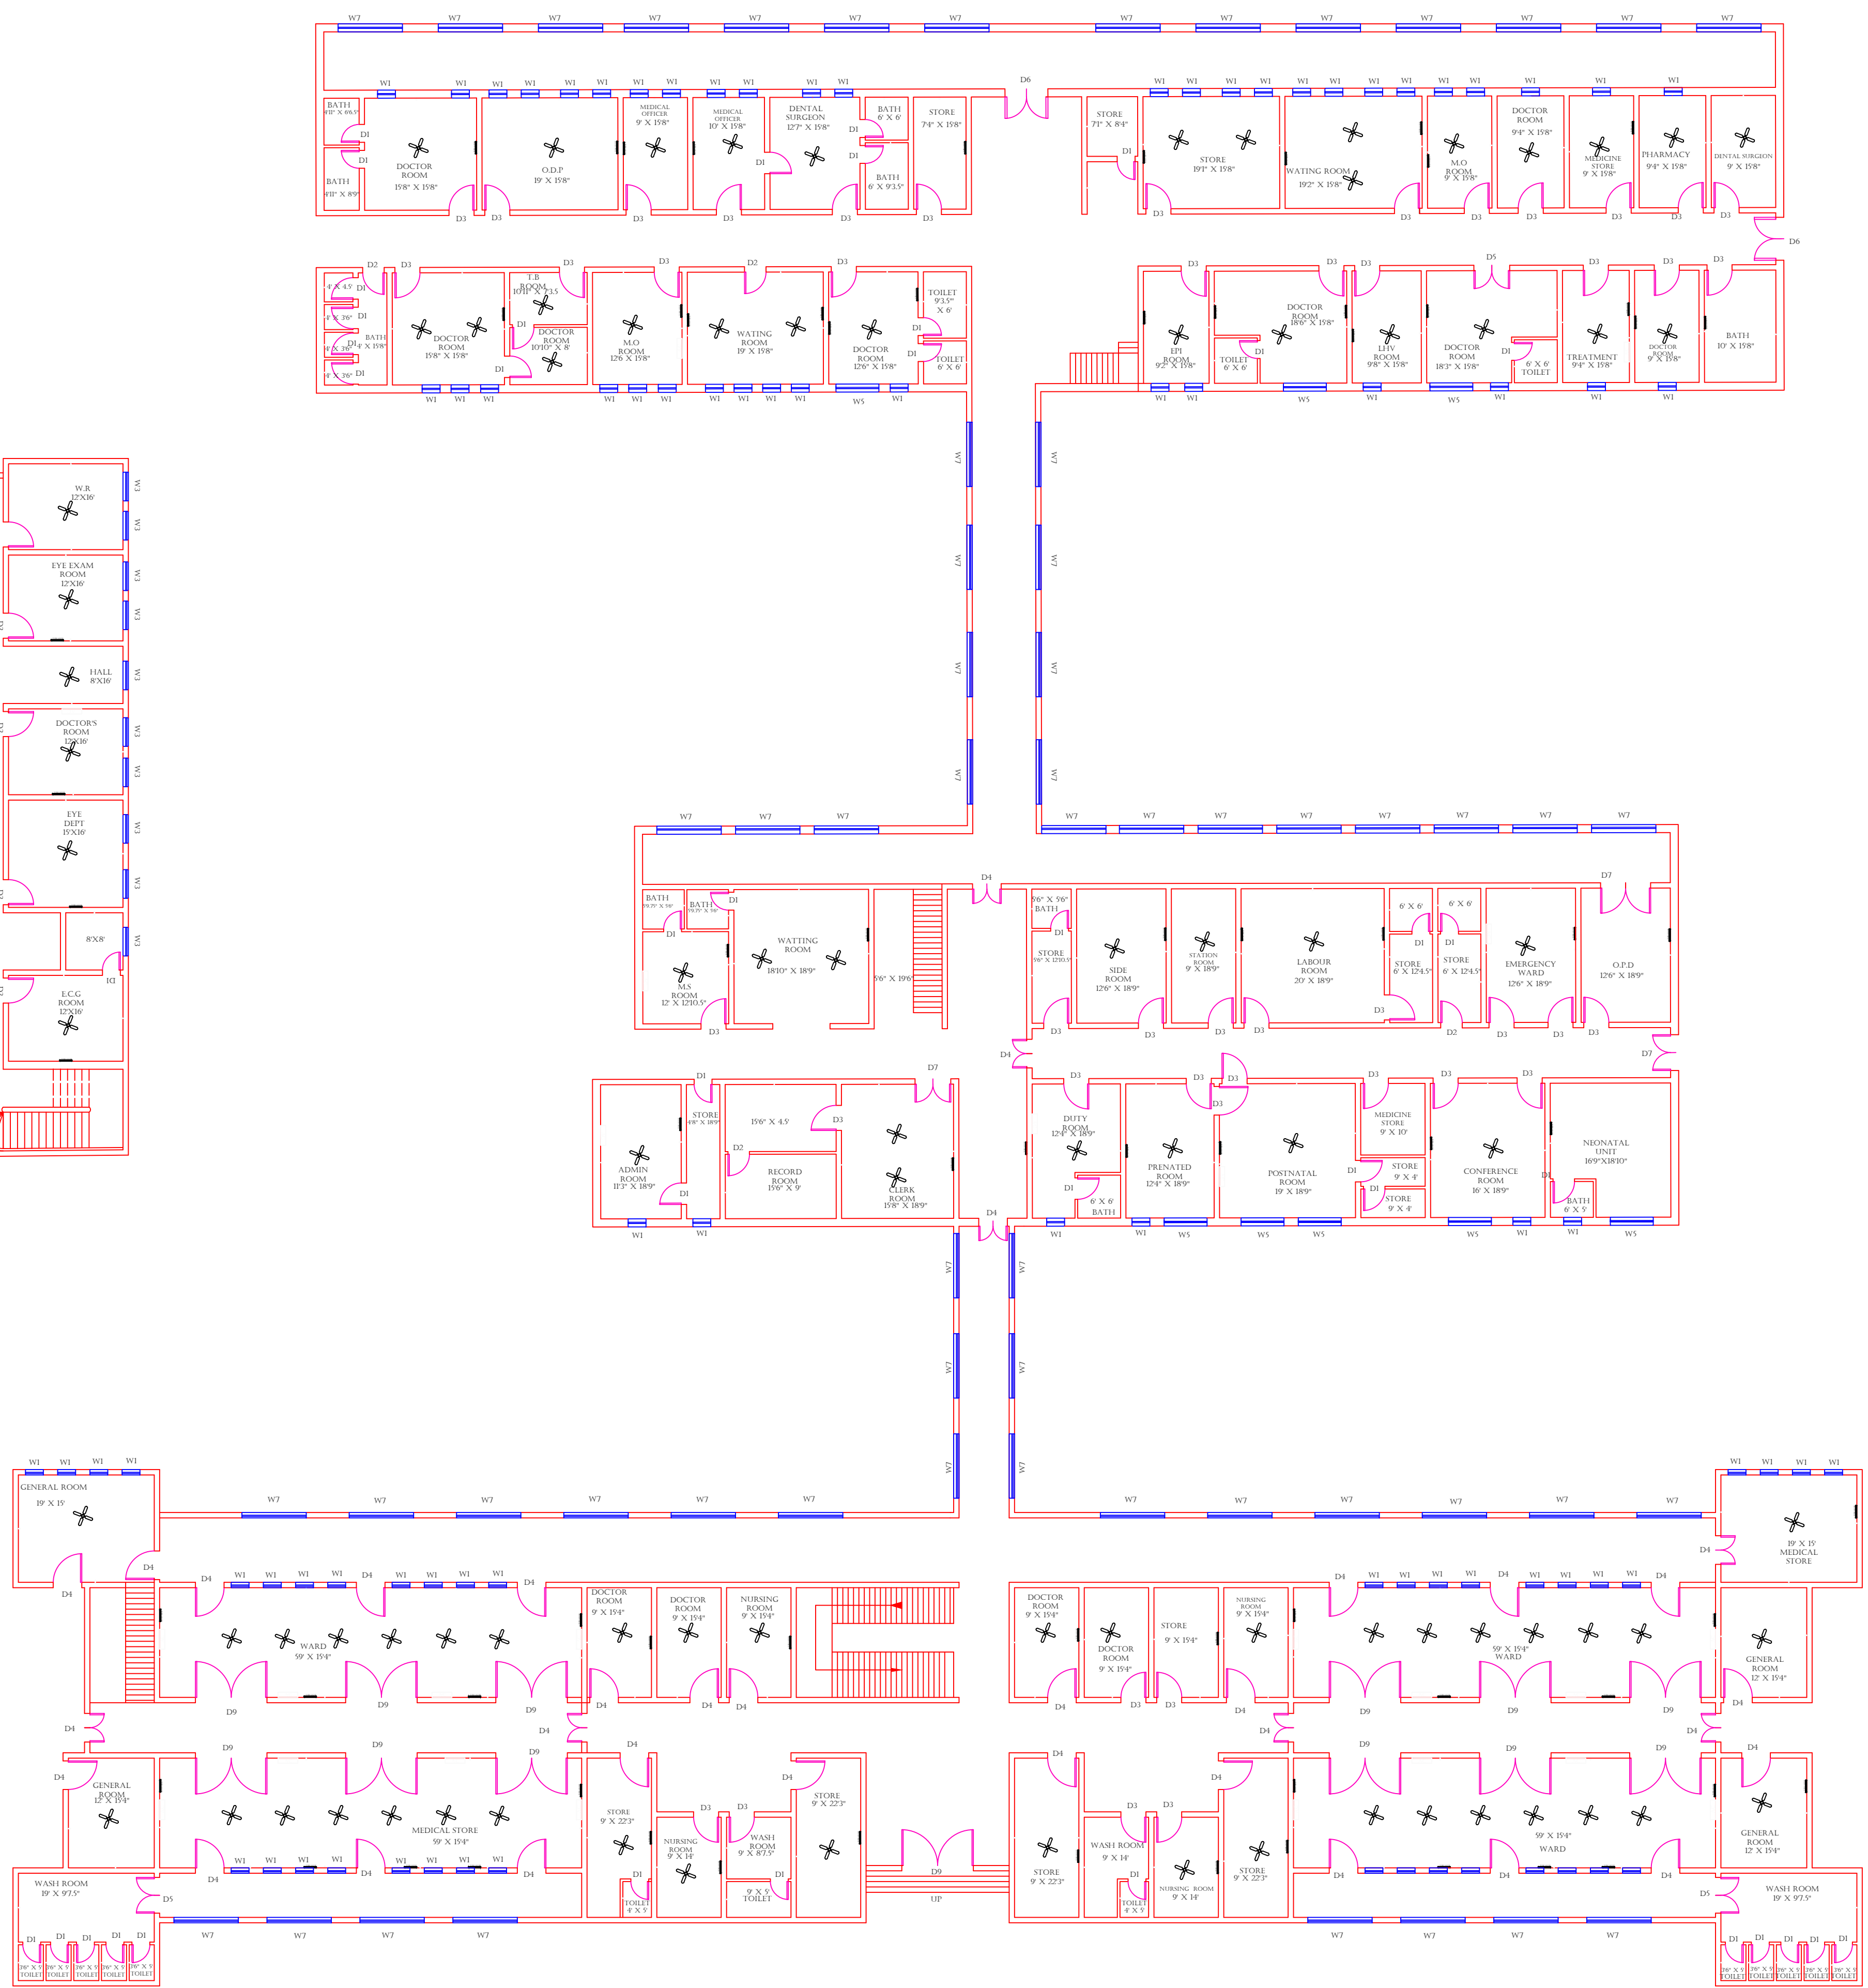

MAIN BUILDING

Legends:

RESIDENTIAL AREA	
ROAD	
WALL	
POWER LINE	
OHT	
TREE	
MANHOLE	
TUBE WELL	
LIGHT POLE	
LAWNS	
EARTHEN AREAS	
ASPHALTS ROADS	
TOUGH PAVERS	
P.C.C /PLINTH PROTECTION	
BOUNDARY WALL	
TAP	
HAND PUMP	
BRICK PAVERS	
AIR CONDITIONER	
TUBE LIGHT	
FAN	
ROOF LIGHT	
BULB	

AREA	
AREA WITHIN BOUNDARY WALL	255225.47 SFT
AREA OF CLINICAL BLOCK	146477.89 SFT
PLINTH AREA OF BLOCK	89148.993 SFT

OPENING SCHEDULE OF DOORS AND WINDOWS					
DOORS	WIDTH	HEIGHT	WINDOWS	WIDTH	HEIGHT
D1	2'-6"	7'-0"	W1	2'-6"	2'-6"
D2	3'-0"	7'-0"	W2	3'-0"	3'-0"
D3	3'-6"	7'-0"	W3	4'-0"	4'-0"
D4	4'-0"	7'-0"	W4	5'-0"	5'-0"
D5	5'-0"	7'-0"	W5	6'-0"	6'-0"
D6	6'-0"	7'-0"	W6	8'-0"	8'-0"
D7	7'-0"	7'-0"	W7	9'-0"	9'-0"
D8	8'-0"	7'-0"	V1		
D9			V2		

Client:

GOVERNMENT OF THE PUNJAB
PRIMARY & SECONDARY
HEALTHCARE DEPARTMENT

Project:

CAD MAPPING OF TEHSIL
HEAD QUARTER HOSPITALS,
PUNJAB

Consultant:

SKAFS CONSULTANT (Pvt.) Limited
ENGINEERING AND ENVIRONMENT CONSULTANT


Drawing Title:

THQ GUJARKHAN
ELECTRICAL LAYOUT
GROUND FLOOR

Authorized By: SKAFS	Reviewed By Co-Team Leader	Scale:
Prepared By: CAD TEAMS	Date: FEB, 2017	
Drawing No.		SKAFS/GUJARKHAN/14

ELECTRICAL LAYOUT PLAN OF THQ HOSPITAL GUJAR KHAN

FIRST FLOOR

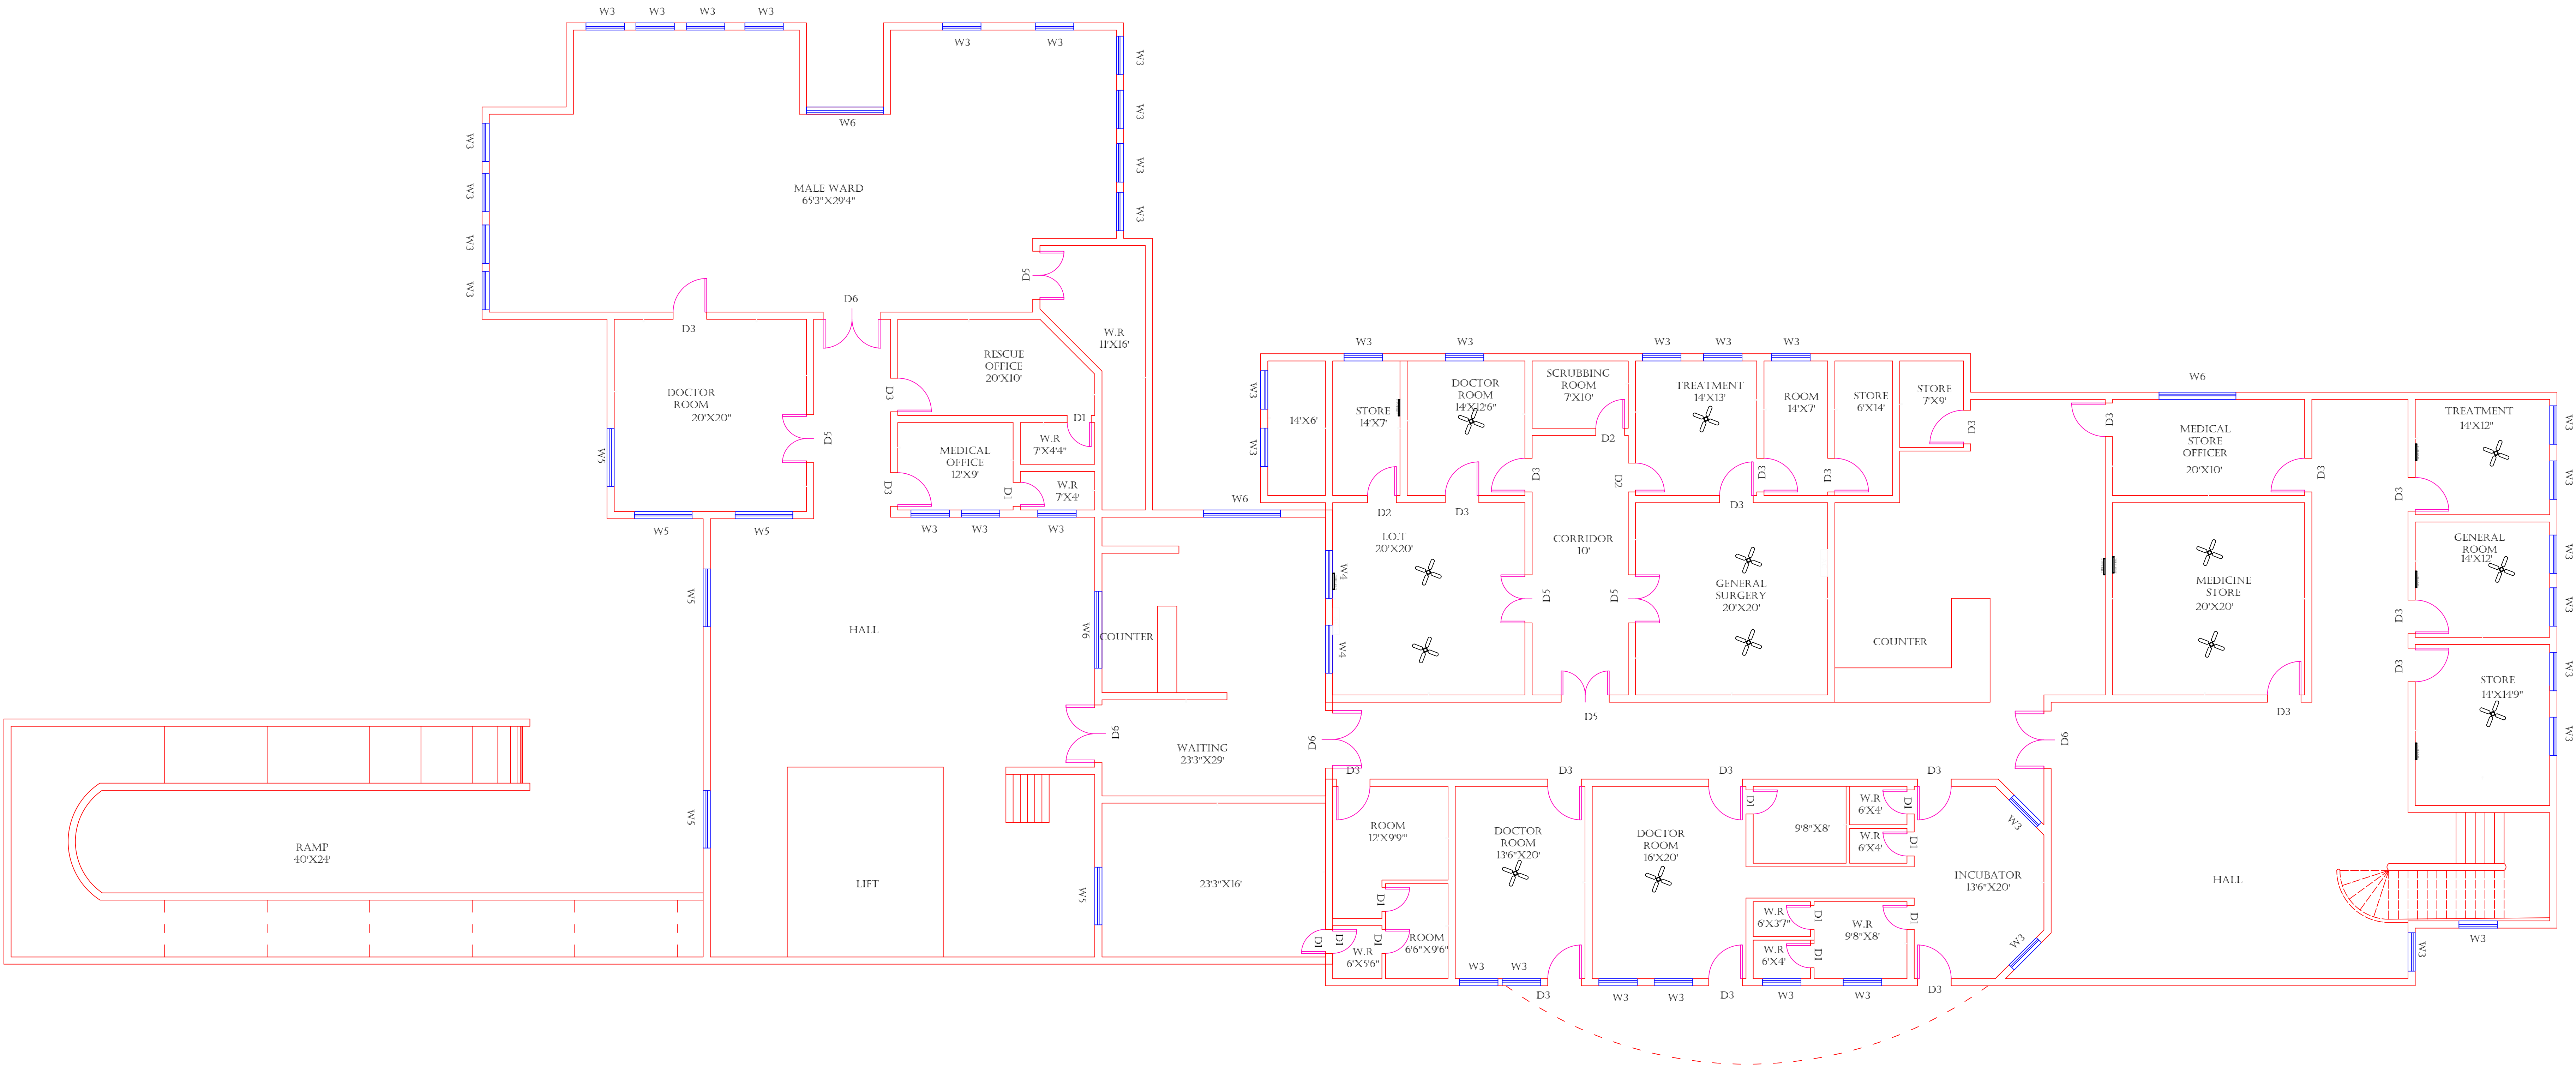

FIRST FLOOR EMERGENCY

Legends:

RESIDENTIAL AREA	
ROAD	
WALL	
POWER LINE	
OHT	
TREE	
MANHOLE	
TUBE WELL	
LIGHT POLE	
LAWNS	
EARTHEN AREAS	
ASPHALTS ROADS	
TOUGH PAVERS	
P.C.C /PLINTH PROTECTION	
BOUNDARY WALL	
TAP	
HAND PUMP	
BRICK PAVERS	
AIR CONDITIONER	
TUBE LIGHT	
FAN	
ROOF LIGHT	
BULB	

AREA	
AREA WITHIN BOUNDARY WALL	255225.47 SFT
AREA OF CLINICAL BLOCK	146477.89 SFT
PLINTH AREA OF BLOCK	89148.993 SFT

OPENING SCHEDULE OF DOORS AND WINDOWS					
DOORS	WIDTH	HEIGHT	WINDOWS	WIDTH	HEIGHT
D1	2'-6"	7'-0"	W1	2'-6"	2'-6"
D2	3'-0"	7'-0"	W2	3'-0"	3'-0"
D3	3'-6"	7'-0"	W3	4'-0"	4'-0"
D4	4'-0"	7'-0"	W4	5'-0"	5'-0"
D5	5'-0"	7'-0"	W5	6'-0"	6'-0"
D6	6'-0"	7'-0"	W6	8'-0"	8'-0"
D7	7'-0"	7'-0"	W7	9'-0"	9'-0"
D8	8'-0"	7'-0"	V1		
D9			V2		

Client:



**GOVERNMENT OF THE PUNJAB
PRIMARY & SECONDARY
HEALTHCARE DEPARTMENT**

Project:

**CAD MAPPING OF TEHSIL
HEAD QUARTER HOSPITALS,
PUNJAB**

Consultant:



SKAFS CONSULTANT (Pvt.) Limited
ENGINEERING AND ENVIRONMENT CONSULTANT

Drawing Title:

**THQ GUJARKHAN
ELECTRICAL LAYOUT
FIRST FLOOR**

Authorized By: SKAFS	Reviewed By Co-Team Leader	Scale:
Prepared By: CAD TEAMS	Date: FEB, 2017	
Drawing No.		SKAFS/GUJARKHAN/15