


MASTER PLAN OF THQ HOSPITAL HASSAN ABDAL

PART 1

PART 2

PART 3

PART 4

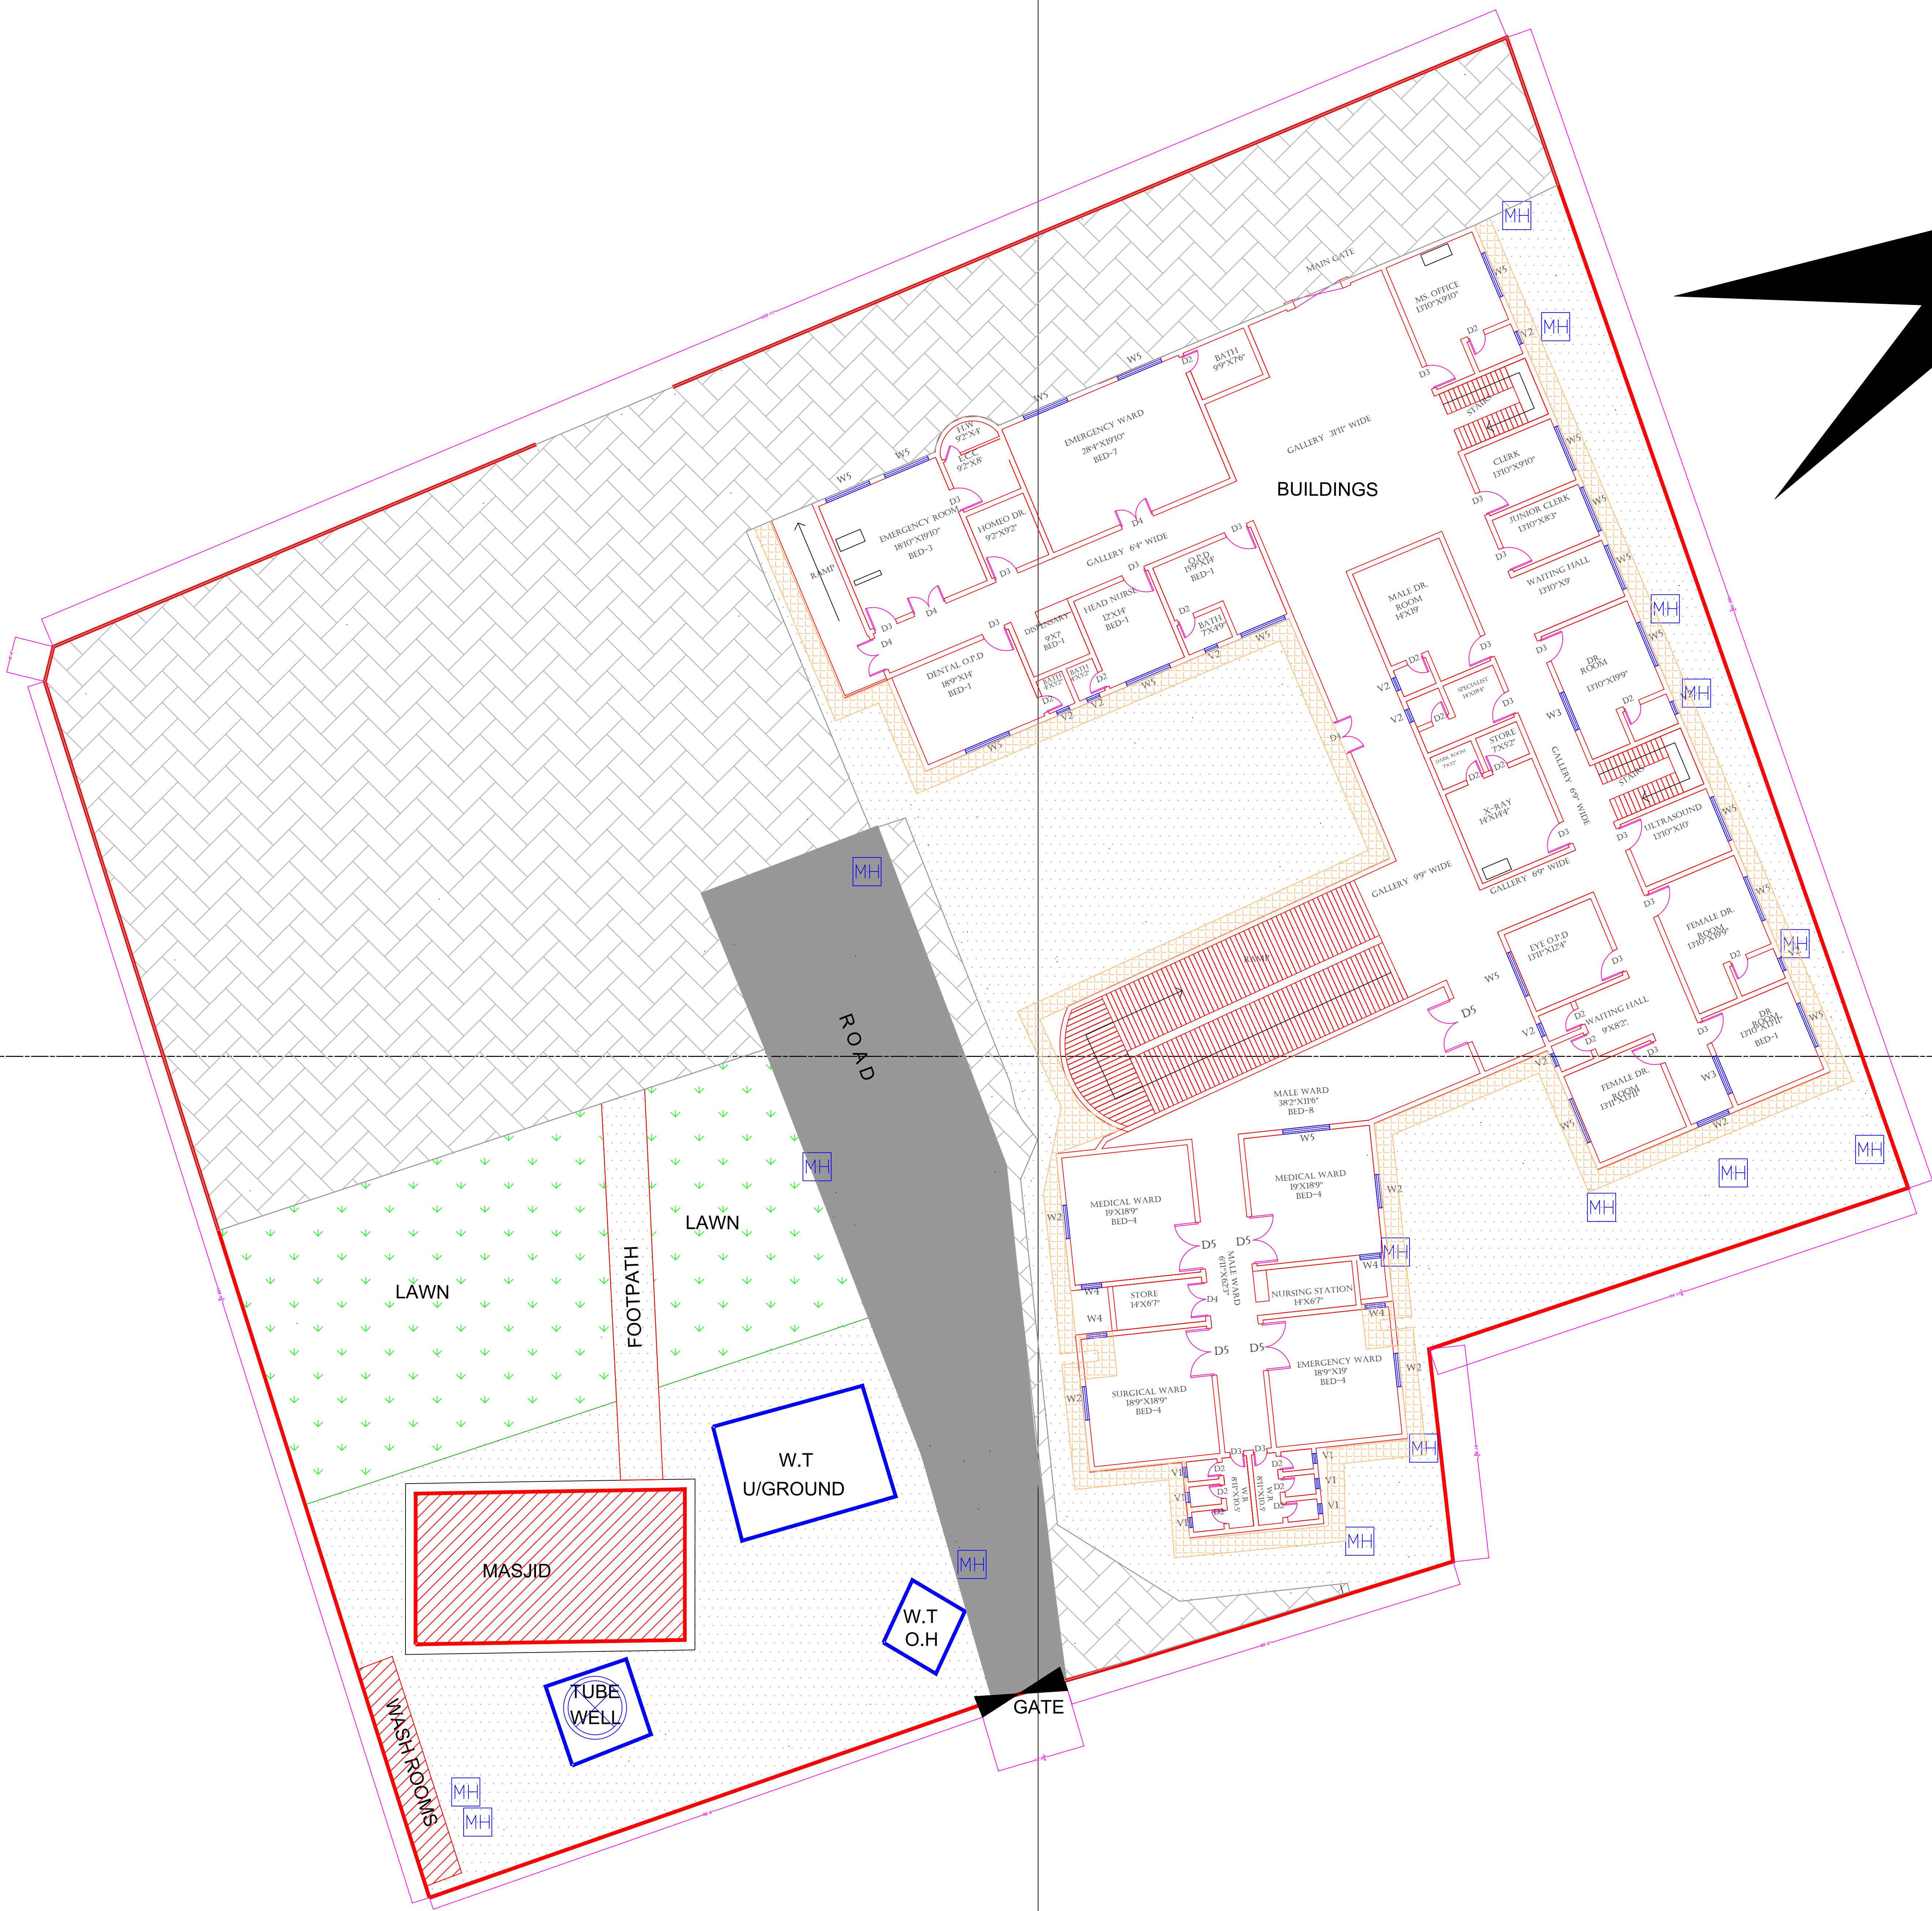

Legends:

RESIDENTIAL AREA	
ROAD	
WALL	
POWER LINE	
OHT	
TREE	
MANHOLE	
TUBE WELL	
LIGHT POLE	
LAWNS	
EARTHEN AREAS	
ASPHALTS ROADS	
TOUGH PAVERS	
P.C.C /PLINTH PROTECTION	
BOUNDARY WALL	
TAP	
HAND PUMP	
BRICK PAVERS	
AIR CONDITIONER	
TUBE LIGHT	
FAN	
ROOF LIGHT	
BULB	

AREA	
AREA WITHIN BOUNDARY WALL	6640307.6284 SFT
AREA OF CLINICAL BLOCK	3820285.0024 SFT
PLINTH AREA OF BLOCK	1910142.5012 SFT

OPENING SCHEDULE OF DOORS AND WINDOWS					
DOORS	WIDTH	HEIGHT	WINDOWS	WIDTH	HEIGHT
D1	3'-6"	8'-3"	W1	4'-0"	5'-6"
D2	2'-6"	7'-0"	W2	5'-0"	3'-6"
D3	4'-0"	8'-3"	W3	6'-0"	5'-6"
D4	3'-0"	8'-3"	W4	3'-0"	8'-3"
D5			W5	6'-0"	7'-0"
D6			W6	3'-0"	5'-6"
D7			V1	4'-0"	1'-6"
D8			V2	4'-0"	3'-0"
D9					

Client:

GOVERNMENT OF THE PUNJAB
PRIMARY & SECONDARY
HEALTHCARE DEPARTMENT

Project:

CAD MAPPING OF TEHSIL
HEAD QUARTER HOSPITALS,
PUNJAB

Consultant:

SKAFS CONSULTANT (Pvt.) Limited
ENGINEERING AND ENVIRONMENT CONSULTANT


Drawing Title:

THQ HASSAN ABDAL
HOSPITAL MASTER PLAN

Authorized By: SKAFS	Reviewed By Co-Team Leader	Scale: 1:250
Prepared By: CAD TEAMS	Date: FEB, 2017	
Drawing No. SKAFS/HASSAN ABDAL/03		

MASTER PLAN OF THQ HOSPITAL HASSAN ABDAL

PART 1

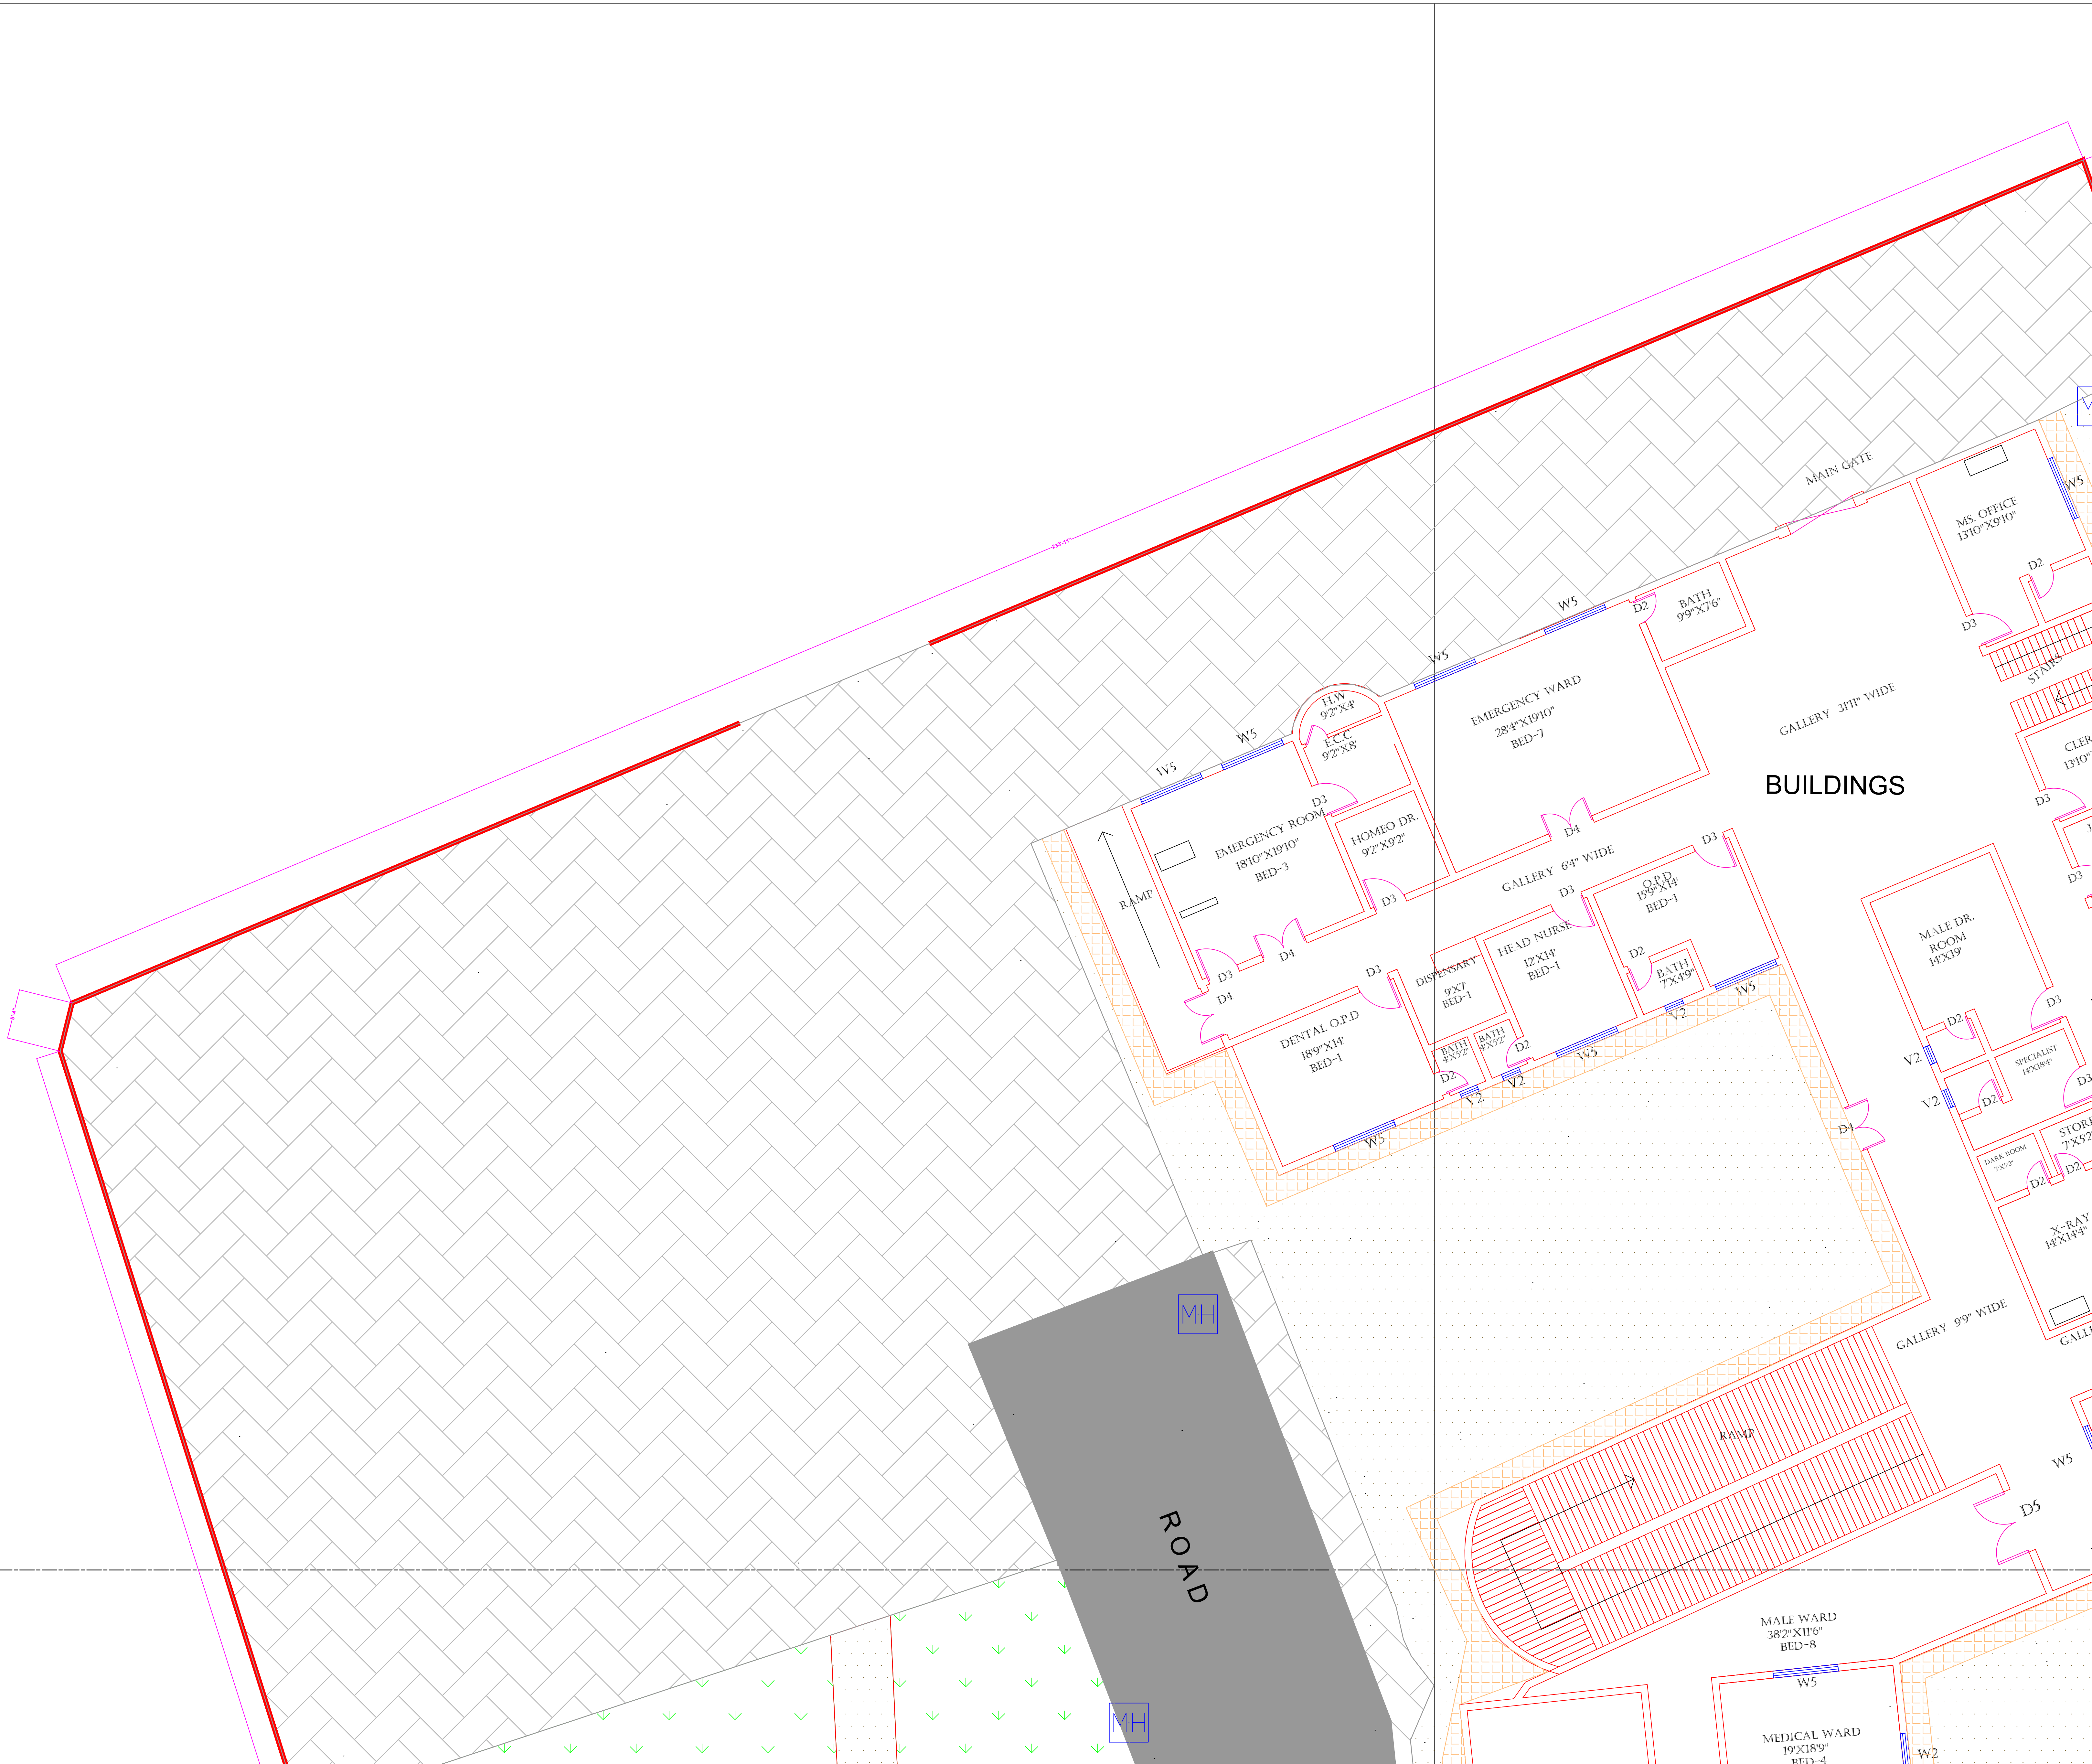

Legends:

RESIDENTIAL AREA	
ROAD	
WALL	
POWER LINE	
OHT	
TREE	
MANHOLE	
TUBE WELL	
LIGHT POLE	
LAWNS	
EARTHEN AREAS	
ASPHALTS ROADS	
TOUGH PAVERS	
P.C.C /PLINTH PROTECTION	
BOUNDARY WALL	
TAP	
HAND PUMP	
BRICK PAVERS	
AIR CONDITIONER	
TUBE LIGHT	
FAN	
ROOF LIGHT	
BULB	

AREA	
AREA WITHIN BOUNDARY WALL	6640307.6284 SFT
AREA OF CLINICAL BLOCK	3820285.0024 SFT
PLINTH AREA OF BLOCK	1910142.5012 SFT

OPENING SCHEDULE OF DOORS AND WINDOWS					
DOORS	WIDTH	HEIGHT	WINDOWS	WIDTH	HEIGHT
D1	3'-6"	8'-3"	W1	4'-0"	5'-6"
D2	2'-6"	7'-0"	W2	5'-0"	3'-6"
D3	4'-0"	8'-3"	W3	6'-0"	5'-6"
D4	3'-0"	8'-3"	W4	3'-0"	8'-3"
D5			W5	6'-0"	7'-0"
D6			W6	3'-0"	5'-6"
D7			V1	4'-0"	1'-6"
D8			V2	4'-0"	3'-0"
D9					

Client:



GOVERNMENT OF THE PUNJAB
PRIMARY & SECONDARY
HEALTHCARE DEPARTMENT

Project:

CAD MAPPING OF TEHSIL
HEAD QUARTER HOSPITALS,
PUNJAB

Consultant:



SKAFS CONSULTANT (Pvt.) Limited
ENGINEERING AND ENVIRONMENT CONSULTANT

Drawing Title:

THQ HASSAN ABDAL
HOSPITAL MASTER PLAN
PART 1

Authorized By: SKAFS	Reviewed By Co-Team Leader	Scale:
Prepared By: CAD TEAMS	Date: FEB, 2017	Sheet:
Drawing No.		SKAFS/HASSAN ABDAL/04

[illegible]

RESIDENTIAL AREA	
ROAD	
WALL	
POWER LINE	
OHT	
TREE	
MANHOLE	
TUBE WELL	
LIGHT POLE	
LAWNS	
EARTHEN AREAS	
ASPHALT'S ROADS	
TOUGH PAVERS	
P.C.C /PLINTH PROTECTION	
BOUNDARY WALL	
TAP	
HAND PUMP	
BRICK PAVERS	
AIR CONDITIONER	
TUBE LIGHT	
FAN	
ROOF LIGHT	
BULB	

AREA	
AREA WITHIN BOUNDARY WALL	6640307.6284 SFT
AREA OF CLINICAL BLOCK	3820285.0024 SFT
PLINTH AREA OF BLOCK	1910142.5012 SFT

OPENING SCHEDULE OF DOORS AND WINDOWS					
DOORS	WIDTH	HEIGHT	WINDOWS	WIDTH	HEIGHT
D1	3'-6"	8'-3"	W1	4'-0"	5'-6"
D2	2'-6"	7'-0"	W2	5'-0"	3'-6"
D3	4'-0"	8'-3"	W3	6'-0"	5'-6"
D4	3'-0"	8'-3"	W4	3'-0"	8'-3"
D5			W5	6'-0"	7'-0"
D6			W6	3'-0"	5'-6"
D7			V1	4'-0"	1'-6"
D8			V2	4'-0"	3'-0"
D9					

GOVERNMENT OF THE PUNJAB
PRIMARY & SECONDARY
HEALTHCARE DEPARTMENT

CAD MAPPING OF TEHSIL HEAD QUARTER HOSPITALS, PUNJAB



SKAFS
INTERNATIONAL LTD.

SKAFS CONSULTANT (Pvt.) Limited
ENGINEERING AND ENVIRONMENT CONSULTANT

Drawing Title: **THQ HASSAN ABDAL
HOSPITAL MASTER PLAN
PART 2**

Authorized By: SKAFS	Reviewed By Co-Team Leader	Scale:
Prepared By: CAD TEAMS	Date: FEB, 2017	Sheet:
Drawing No.		

SKAFS/HASSAN ABDAL /05

MASTER PLAN OF THQ HOSPITAL HASSAN ABDAL

PART 3



Legends:

RESIDENTIAL AREA	
ROAD	
WALL	
POWER LINE	
OHT	
TREE	
MANHOLE	
TUBE WELL	
LIGHT POLE	
LAWNS	
EARTHEN AREAS	
ASPHALTS ROADS	
TOUGH PAVERS	
P.C.C /PLINTH PROTECTION	
BOUNDARY WALL	
TAP	
HAND PUMP	
BRICK PAVERS	
AIR CONDITIONER	
TUBE LIGHT	
FAN	
ROOF LIGHT	
BULB	

AREA	
AREA WITHIN BOUNDARY WALL	6640307.6284 SFT
AREA OF CLINICAL BLOCK	3820285.0024 SFT
PLINTH AREA OF BLOCK	1910142.5012 SFT

OPENING SCHEDULE OF DOORS AND WINDOWS					
DOORS	WIDTH	HEIGHT	WINDOWS	WIDTH	HEIGHT
D1	3'-6"	8'-3"	W1	4'-0"	5'-6"
D2	2'-6"	7'-0"	W2	5'-0"	3'-6"
D3	4'-0"	8'-3"	W3	6'-0"	5'-6"
D4	3'-0"	8'-3"	W4	3'-0"	8'-3"
D5			W5	6'-0"	7'-0"
D6			W6	3'-0"	5'-6"
D7			V1	4'-0"	1'-6"
D8			V2	4'-0"	3'-0"
D9					

Client:

GOVERNMENT OF THE PUNJAB
PRIMARY & SECONDARY
HEALTHCARE DEPARTMENT

Project:

CAD MAPPING OF TEHSIL
HEAD QUARTER HOSPITALS,
PUNJAB

Consultant:

SKAFS CONSULTANT (Pvt.) Limited
ENGINEERING AND ENVIRONMENT CONSULTANT

Drawing Title:

THQ HASSAN ABDAL
HOSPITAL MASTER PLAN
PART 3


Authorized By: SKAFS	Reviewed By Co-Team Leader	Scale:
Prepared By: CAD TEAMS	Date: FEB, 2017	

Drawing No.

SKAFS/HASSAN ABDAL /06

MASTER PLAN OF THQ HOSPITAL HASSAN ABDAL

PART 4

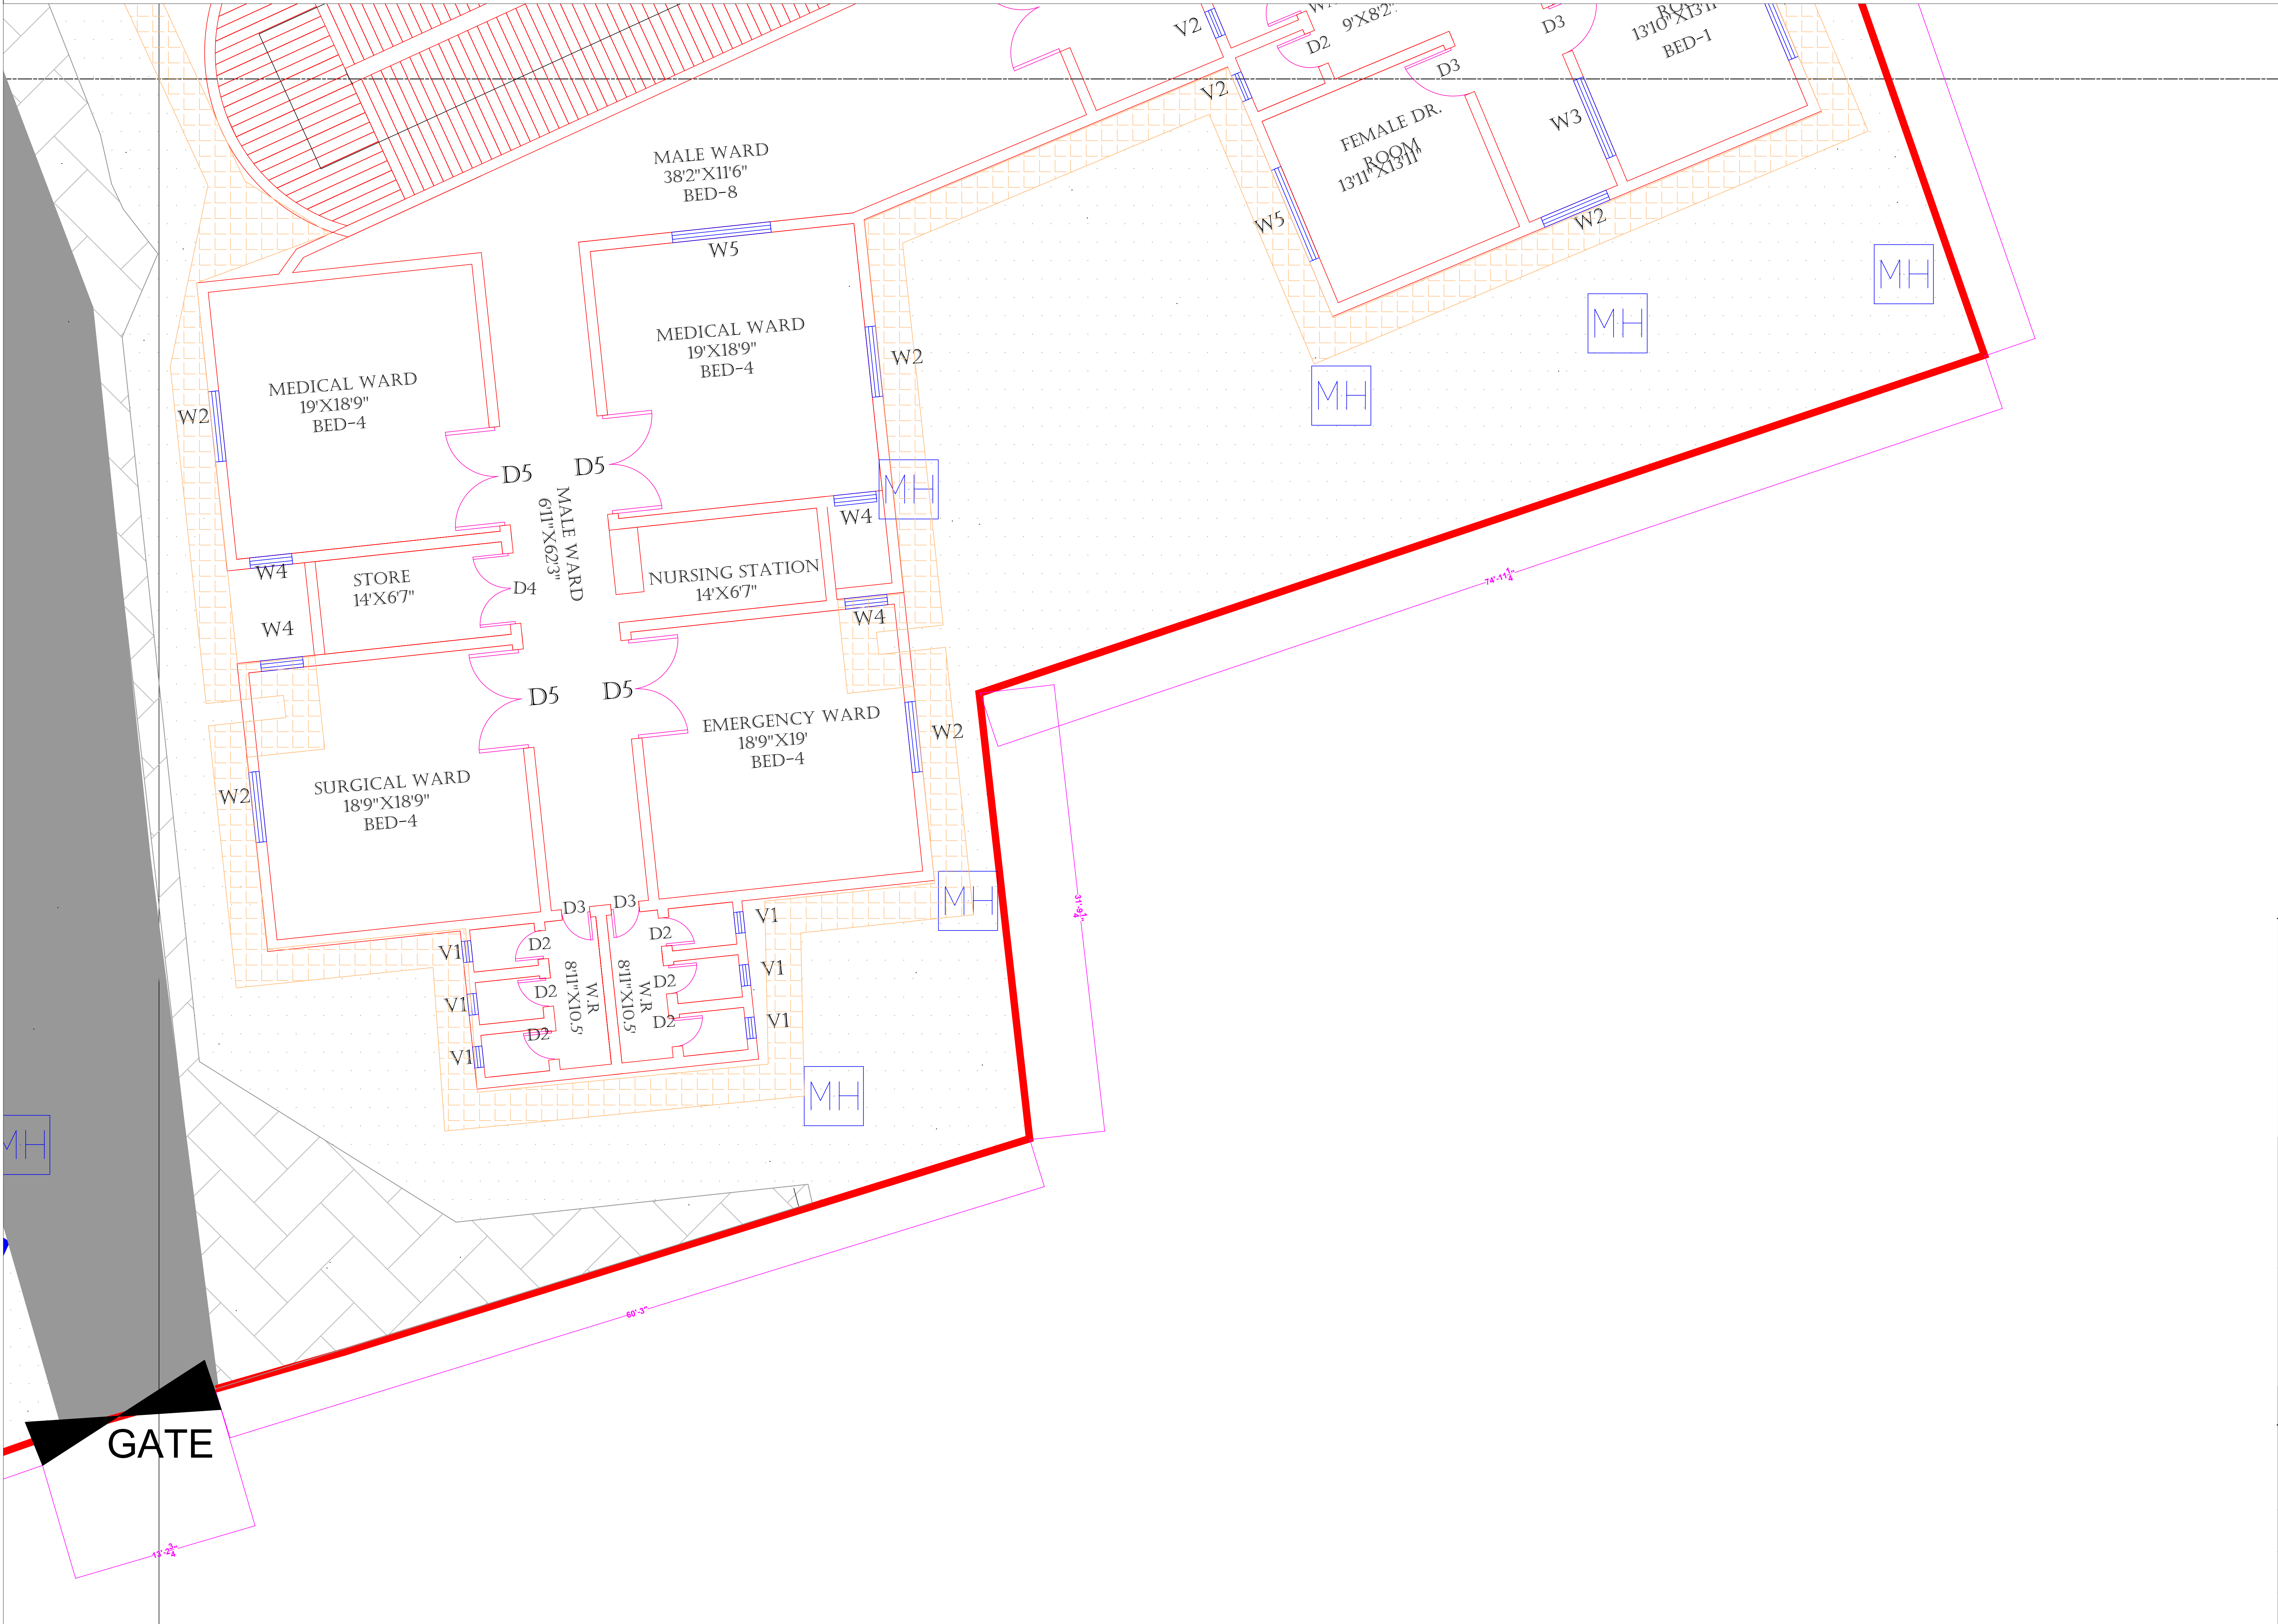

Legends:

RESIDENTIAL AREA	
ROAD	
WALL	
POWER LINE	
OHT	
TREE	
MANHOLE	
TUBE WELL	
LIGHT POLE	
LAWNS	
EARTHEN AREAS	
ASPHALTS ROADS	
TOUGH PAVERS	
P.C.C /PLINTH PROTECTION	
BOUNDARY WALL	
TAP	
HAND PUMP	
BRICK PAVERS	
AIR CONDITIONER	
TUBE LIGHT	
FAN	
ROOF LIGHT	
BULB	

AREA	
AREA WITHIN BOUNDARY WALL	6640307.6284 SFT
AREA OF CLINICAL BLOCK	3820285.0024 SFT
PLINTH AREA OF BLOCK	1910142.5012 SFT

OPENING SCHEDULE OF DOORS AND WINDOWS					
DOORS	WIDTH	HEIGHT	WINDOWS	WIDTH	HEIGHT
D1	3'-6"	8'-3"	W1	4'-0"	5'-6"
D2	2'-6"	7'-0"	W2	5'-0"	3'-6"
D3	4'-0"	8'-3"	W3	6'-0"	5'-6"
D4	3'-0"	8'-3"	W4	3'-0"	8'-3"
D5			W5	6'-0"	7'-0"
D6			W6	3'-0"	5'-6"
D7			V1	4'-0"	1'-6"
D8			V2	4'-0"	3'-0"
D9					

Client:



GOVERNMENT OF THE PUNJAB
PRIMARY & SECONDARY
HEALTHCARE DEPARTMENT

Project:

**CAD MAPPING OF TEHSIL
HEAD QUARTER HOSPITALS,
PUNJAB**

Consultant:



SKAFS CONSULTANT (Pvt.) Limited
ENGINEERING AND ENVIRONMENT CONSULTANT

Drawing Title:

**THQ HASSAN ABDAL
HOSPITAL MASTER PLAN
PART 4**


Authorized By: SKAFS	Reviewed By Co-Team Leader	Scale:
Prepared By: CAD TEAMS	Date: FEB, 2017	
Drawing No. SKAFS/HASSAN ABDAL /07		

CLINICAL BLOCK OF THQ HOSPITAL HASSAN ABDAL

GROUND FLOOR

PART 1

PART 2

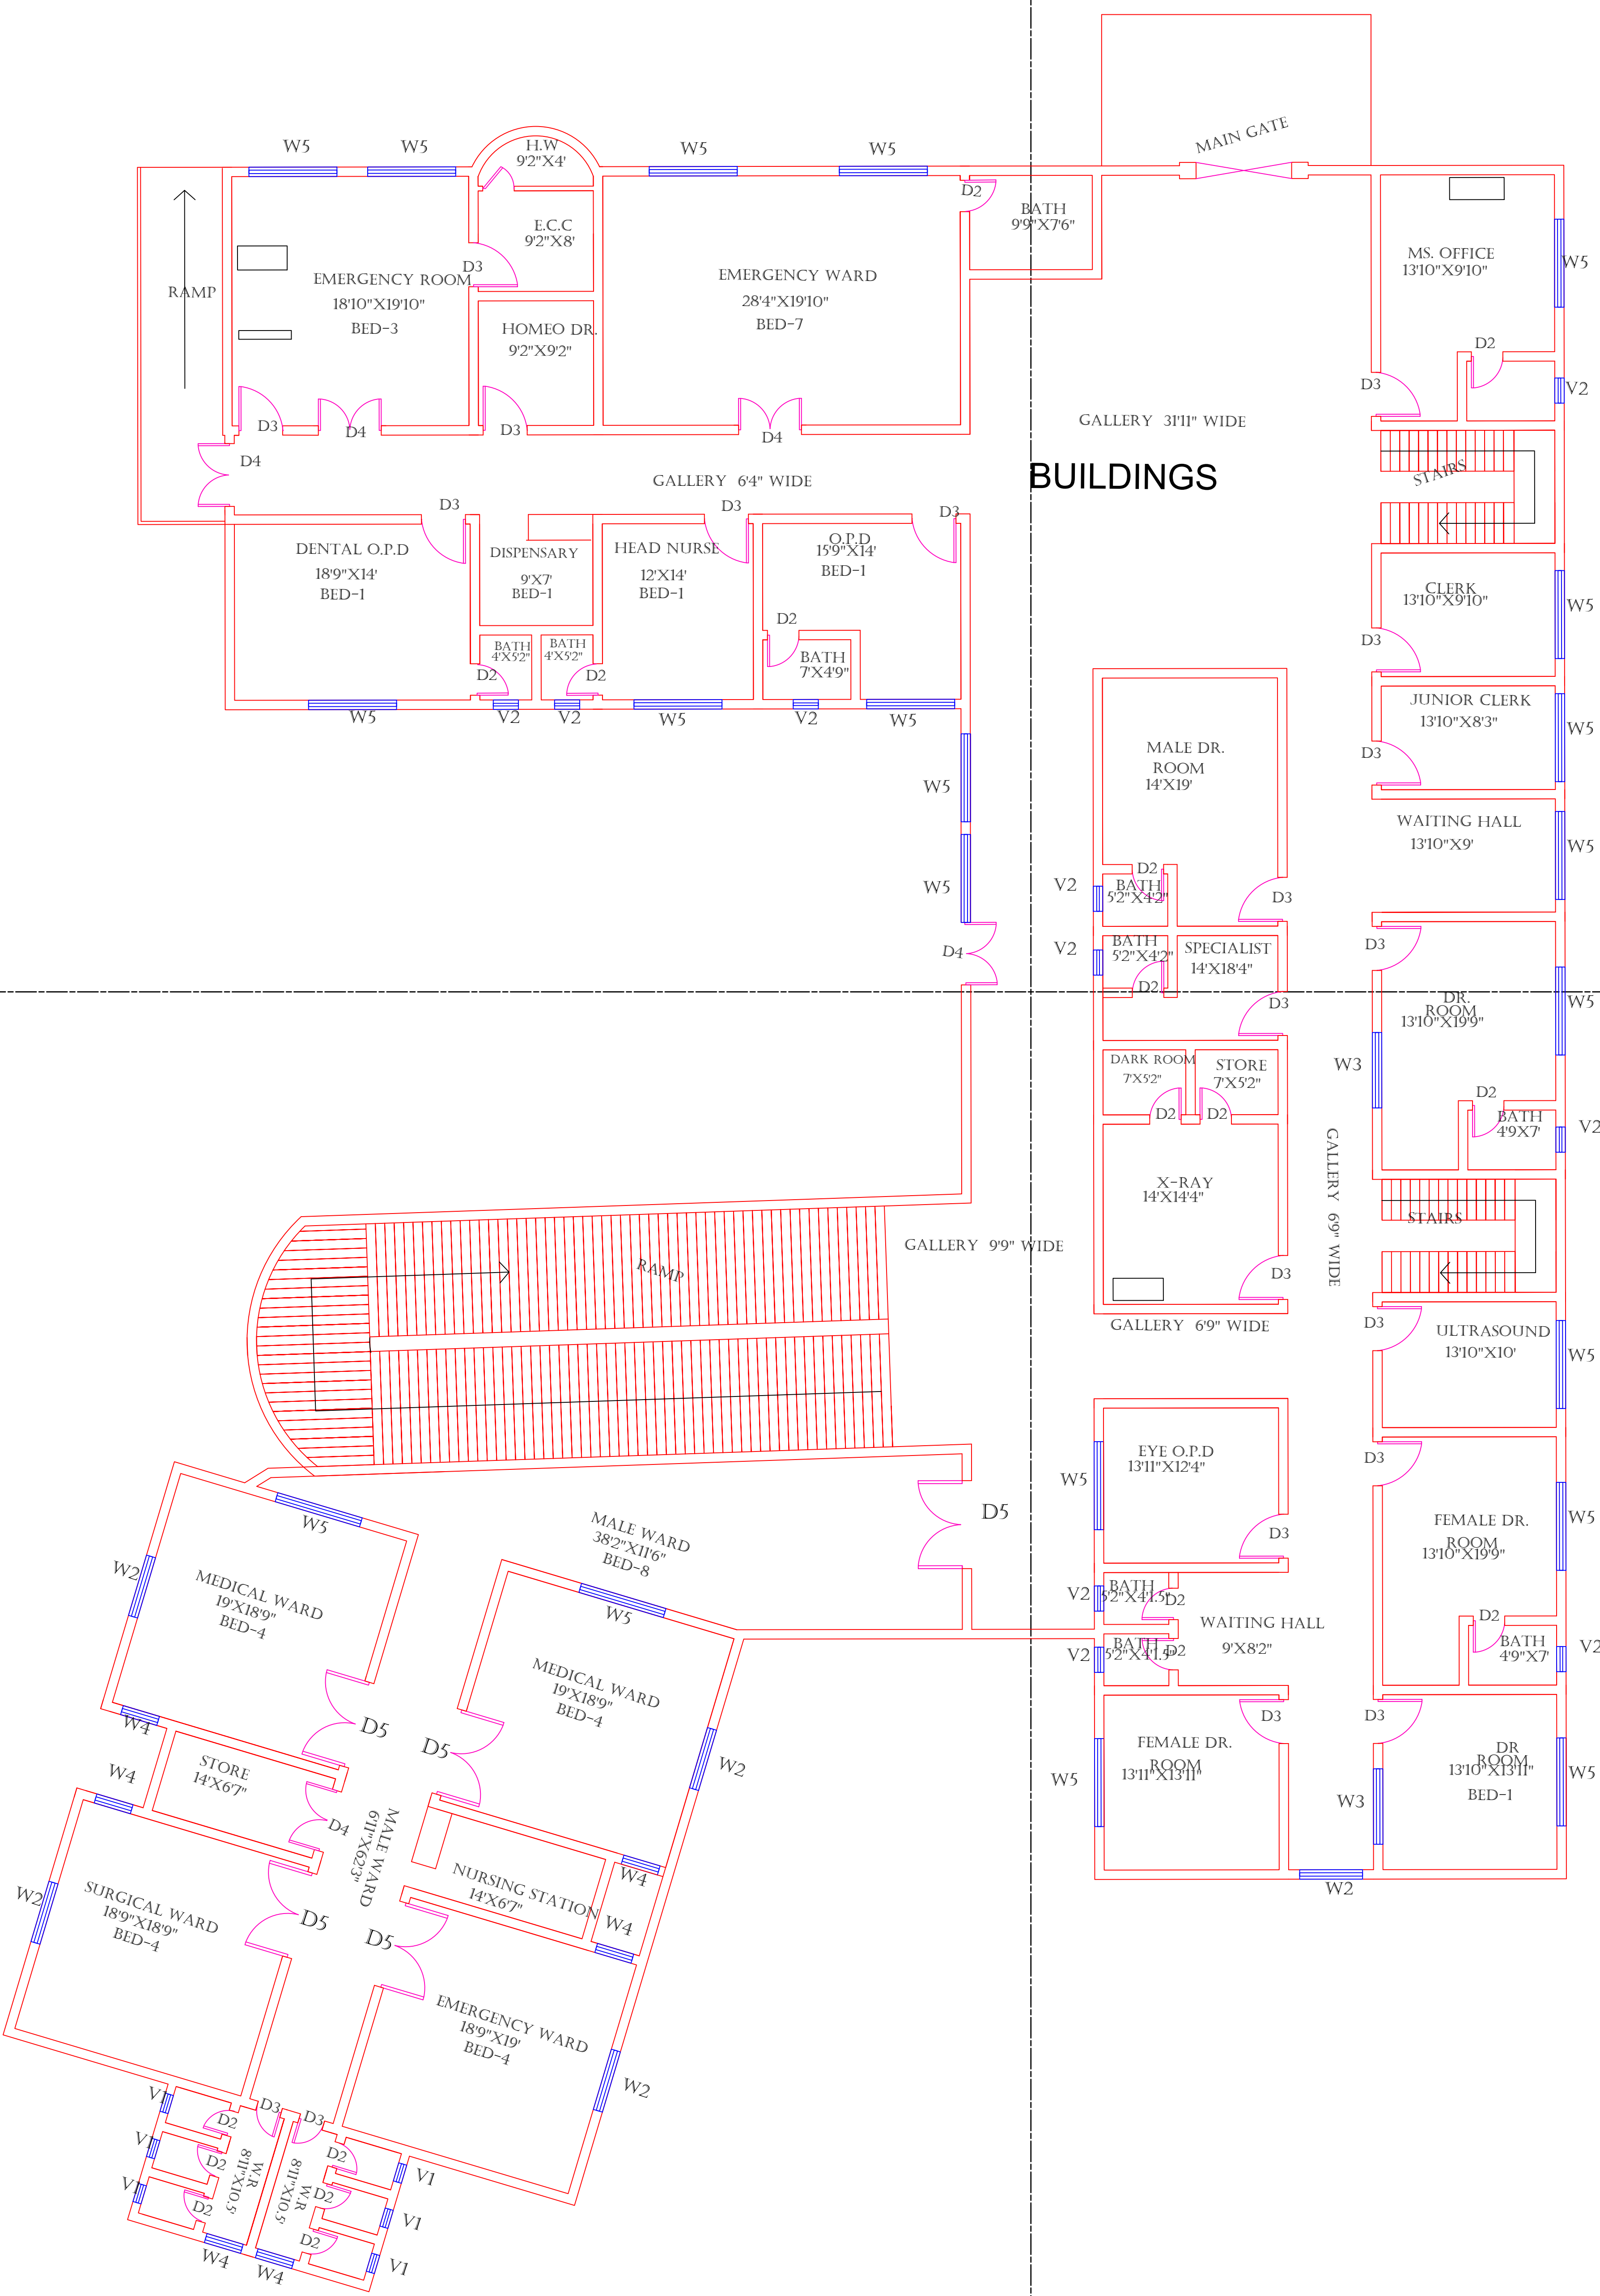

PART 3

PART 4

Legends:

RESIDENTIAL AREA	
ROAD	
WALL	
POWER LINE	
OHT	
TREE	
MANHOLE	
TUBE WELL	
LIGHT POLE	
LAWNS	
EARTHEN AREAS	
ASPHALTS ROADS	
TOUGH PAVERS	
P.C.C /PLINTH PROTECTION	
BOUNDARY WALL	
TAP	
HAND PUMP	
BRICK PAVERS	
AIR CONDITIONER	
TUBE LIGHT	
FAN	
ROOF LIGHT	
BULB	

AREA	
AREA WITHIN BOUNDARY WALL	6640307.6284 SFT
AREA OF CLINICAL BLOCK	3820285.0024 SFT
PLINTH AREA OF BLOCK	1910142.5012 SFT

OPENING SCHEDULE OF DOORS AND WINDOWS					
DOORS	WIDTH	HEIGHT	WINDOWS	WIDTH	HEIGHT
D1	3'-6"	8'-3"	W1	4'-0"	5'-6"
D2	2'-6"	7'-0"	W2	5'-0"	3'-6"
D3	4'-0"	8'-3"	W3	6'-0"	5'-6"
D4	3'-0"	8'-3"	W4	3'-0"	8'-3"
D5			W5	6'-0"	7'-0"
D6			W6	3'-0"	5'-6"
D7			V1	4'-0"	1'-6"
D8			V2	4'-0"	3'-0"
D9					

Client:

GOVERNMENT OF THE PUNJAB
PRIMARY & SECONDARY
HEALTHCARE DEPARTMENT

Project:

CAD MAPPING OF TEHSIL
HEAD QUARTER HOSPITALS,
PUNJAB

Consultant:

SKAFS CONSULTANT (Pvt.) Limited
ENGINEERING AND ENVIRONMENT CONSULTANT


Drawing Title:

THQ HASSAN ABDAL
HOSPITAL MAIN BUILDING
CLINICAL BLOCK PLAN

Authorized By: SKAFS	Reviewed By Co-Team Leader	Scale: 1:250
Prepared By: CAD TEAMS	Date: FEB, 2017	
Drawing No. SKAFS/HASSAN ABDAL/08		

CLINICAL BLOCK OF THQ HOSPITAL HASSAN ABDAL

GROUND FLOOR (PART 1)

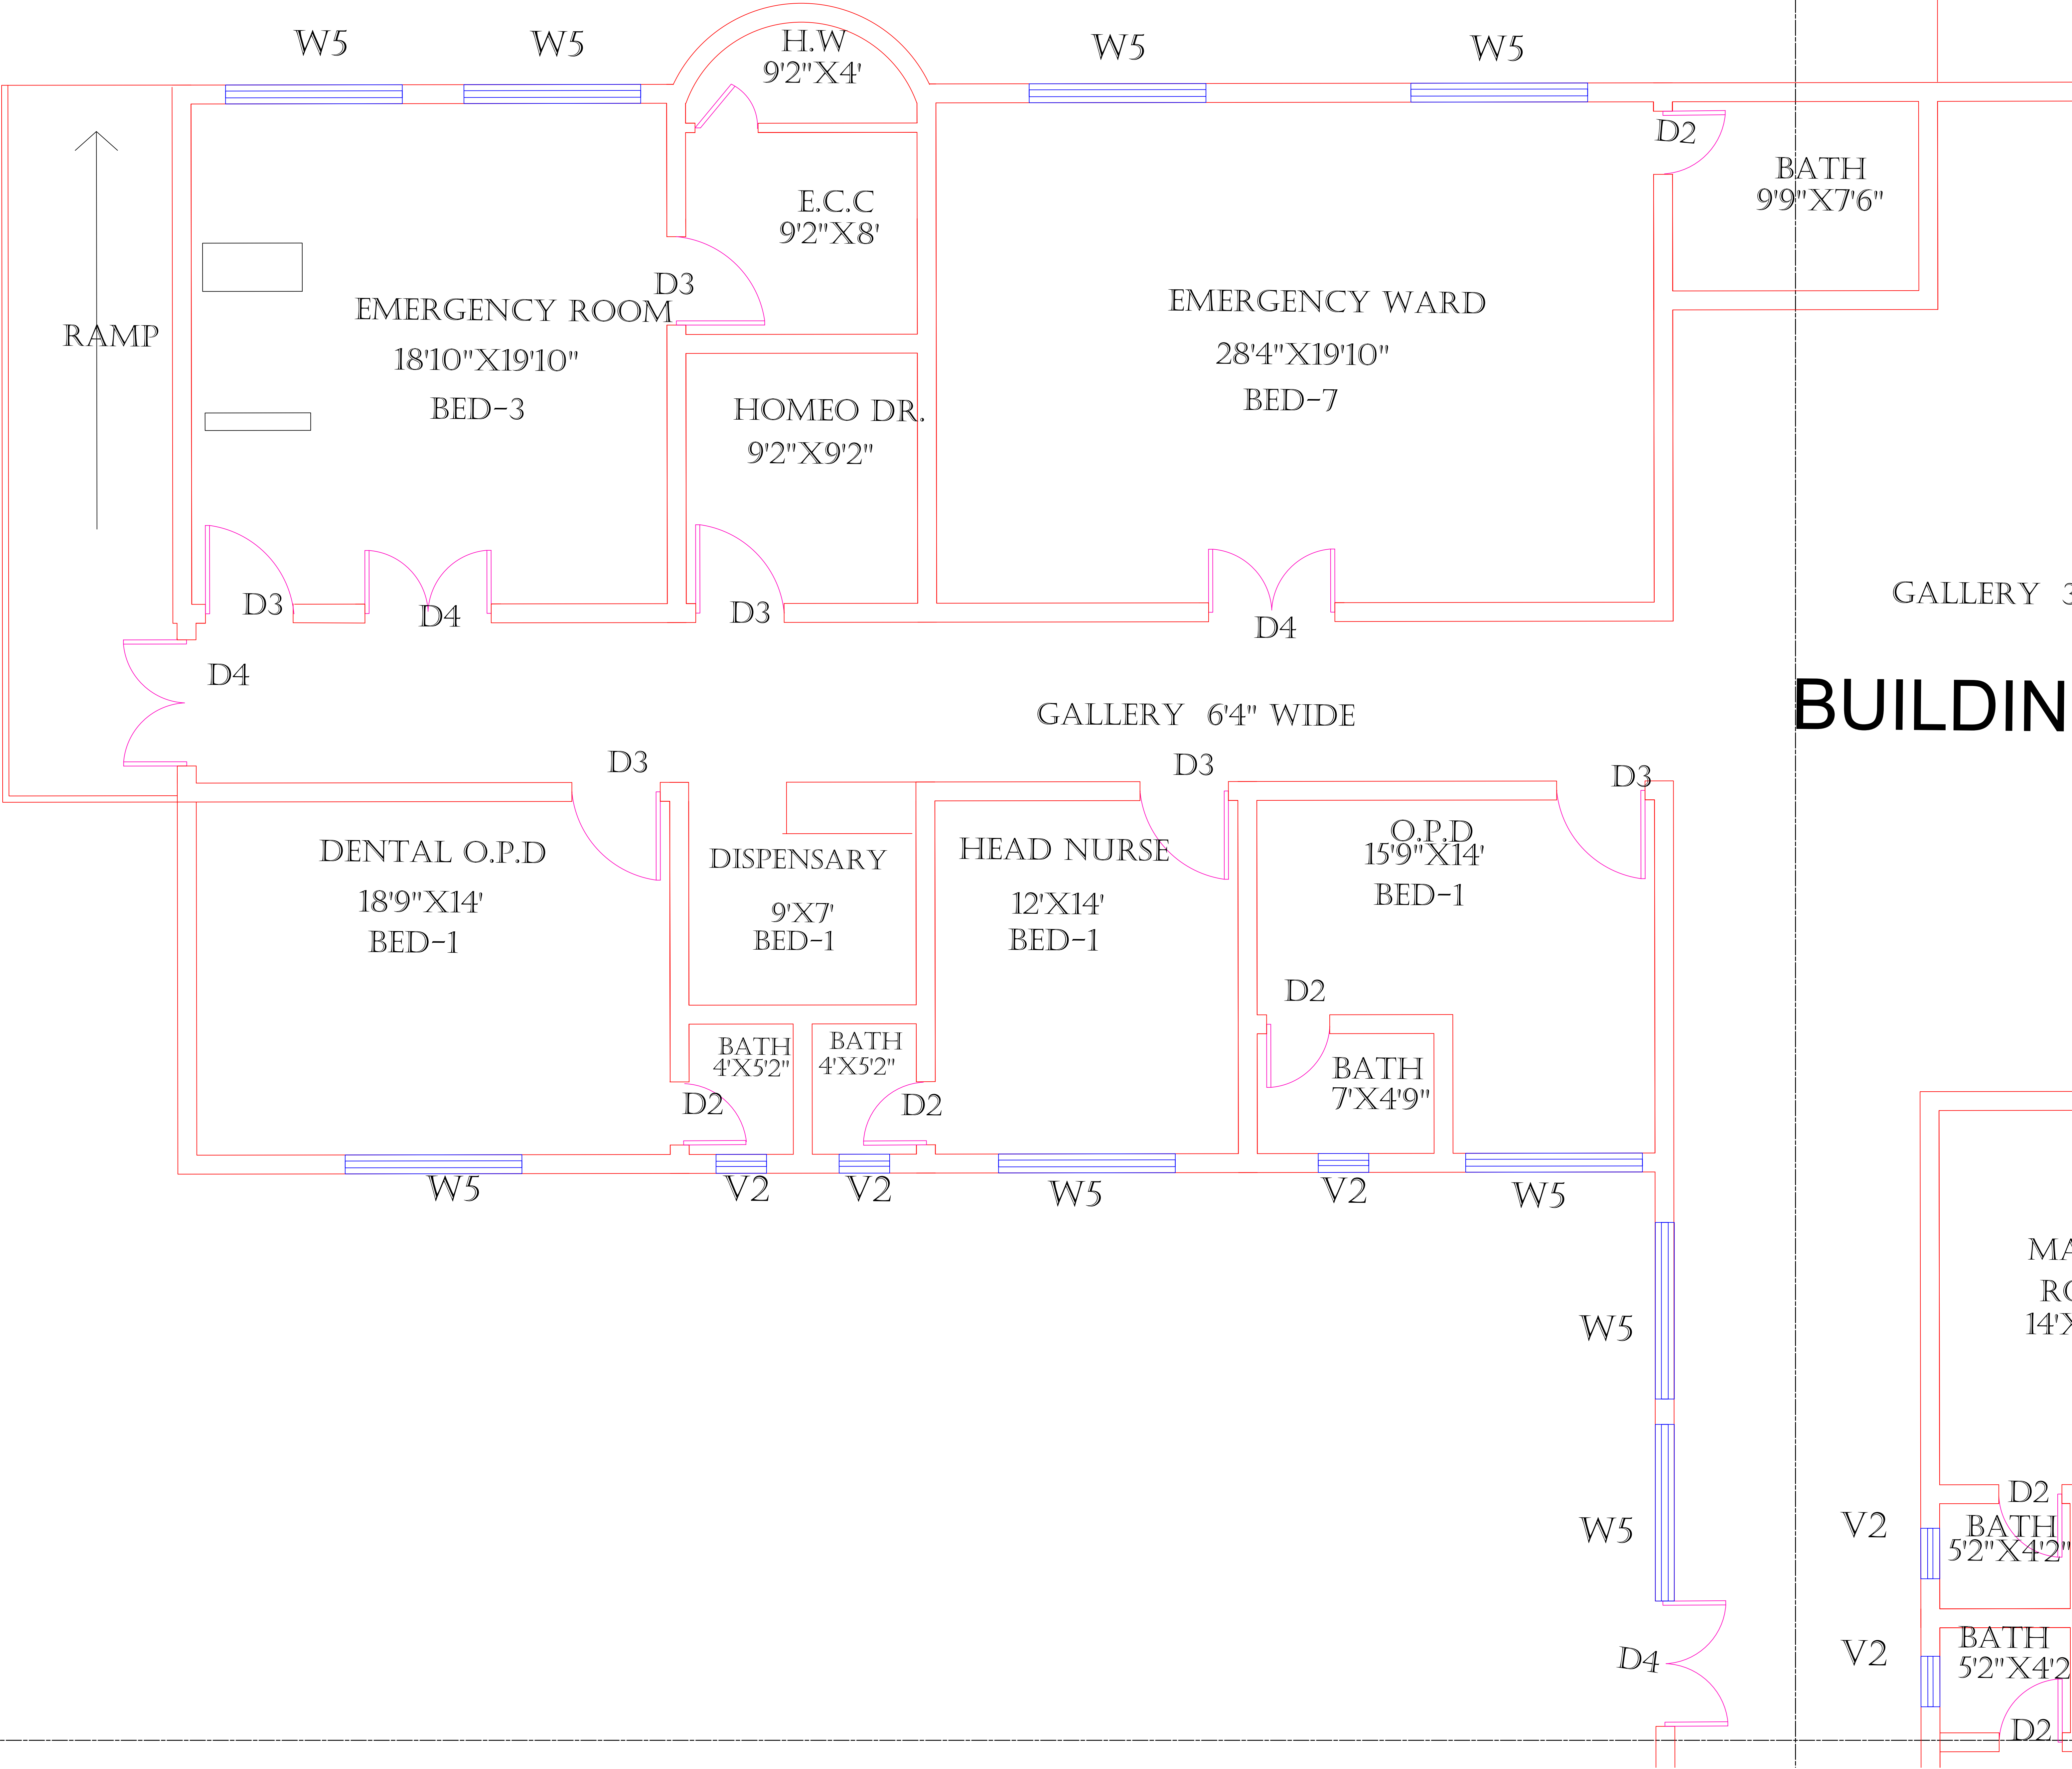

Legends:

RESIDENTIAL AREA	
ROAD	
WALL	
POWER LINE	
OHT	
TREE	
MANHOLE	
TUBE WELL	
LIGHT POLE	
LAWNS	
EARTHEN AREAS	
ASPHALTS ROADS	
TOUGH PAVERS	
P.C.C /PLINTH PROTECTION	
BOUNDARY WALL	
TAP	
HAND PUMP	
BRICK PAVERS	
AIR CONDITIONER	
TUBE LIGHT	
FAN	
ROOF LIGHT	
BULB	

AREA	
AREA WITHIN BOUNDARY WALL	6640307.6284 SFT
AREA OF CLINICAL BLOCK	3820285.0024 SFT
PLINTH AREA OF BLOCK	1910142.5012 SFT

OPENING SCHEDULE OF DOORS AND WINDOWS					
DOORS	WIDTH	HEIGHT	WINDOWS	WIDTH	HEIGHT
D1	3'-6"	8'-3"	W1	4'-0"	5'-6"
D2	2'-6"	7'-0"	W2	5'-0"	3'-6"
D3	4'-0"	8'-3"	W3	6'-0"	5'-6"
D4	3'-0"	8'-3"	W4	3'-0"	8'-3"
D5			W5	6'-0"	7'-0"
D6			W6	3'-0"	5'-6"
D7			V1	4'-0"	1'-6"
D8			V2	4'-0"	3'-0"
D9					

Client:



GOVERNMENT OF THE PUNJAB
PRIMARY & SECONDARY
HEALTHCARE DEPARTMENT

Project:

**CAD MAPPING OF TEHSIL
HEAD QUARTER HOSPITALS,
PUNJAB**

Consultant:




SKAFS CONSULTANT (Pvt.) Limited
ENGINEERING AND ENVIRONMENT CONSULTANT

Drawing Title:

**THQ HASSAN ABDAL
HOSPITAL CLINICAL BLOCK
PART 1**

Authorized By: SKAFS	Reviewed By Co-Team Leader	Scale:
Prepared By: CAD TEAMS	Date: FEB, 2017	
Drawing No. SKAFS/HASSAN ABDAL /09		

CLINICAL BLOCK OF THQ HOSPITAL HASSAN ABDAL
GROUND FLOOR (PART 2)

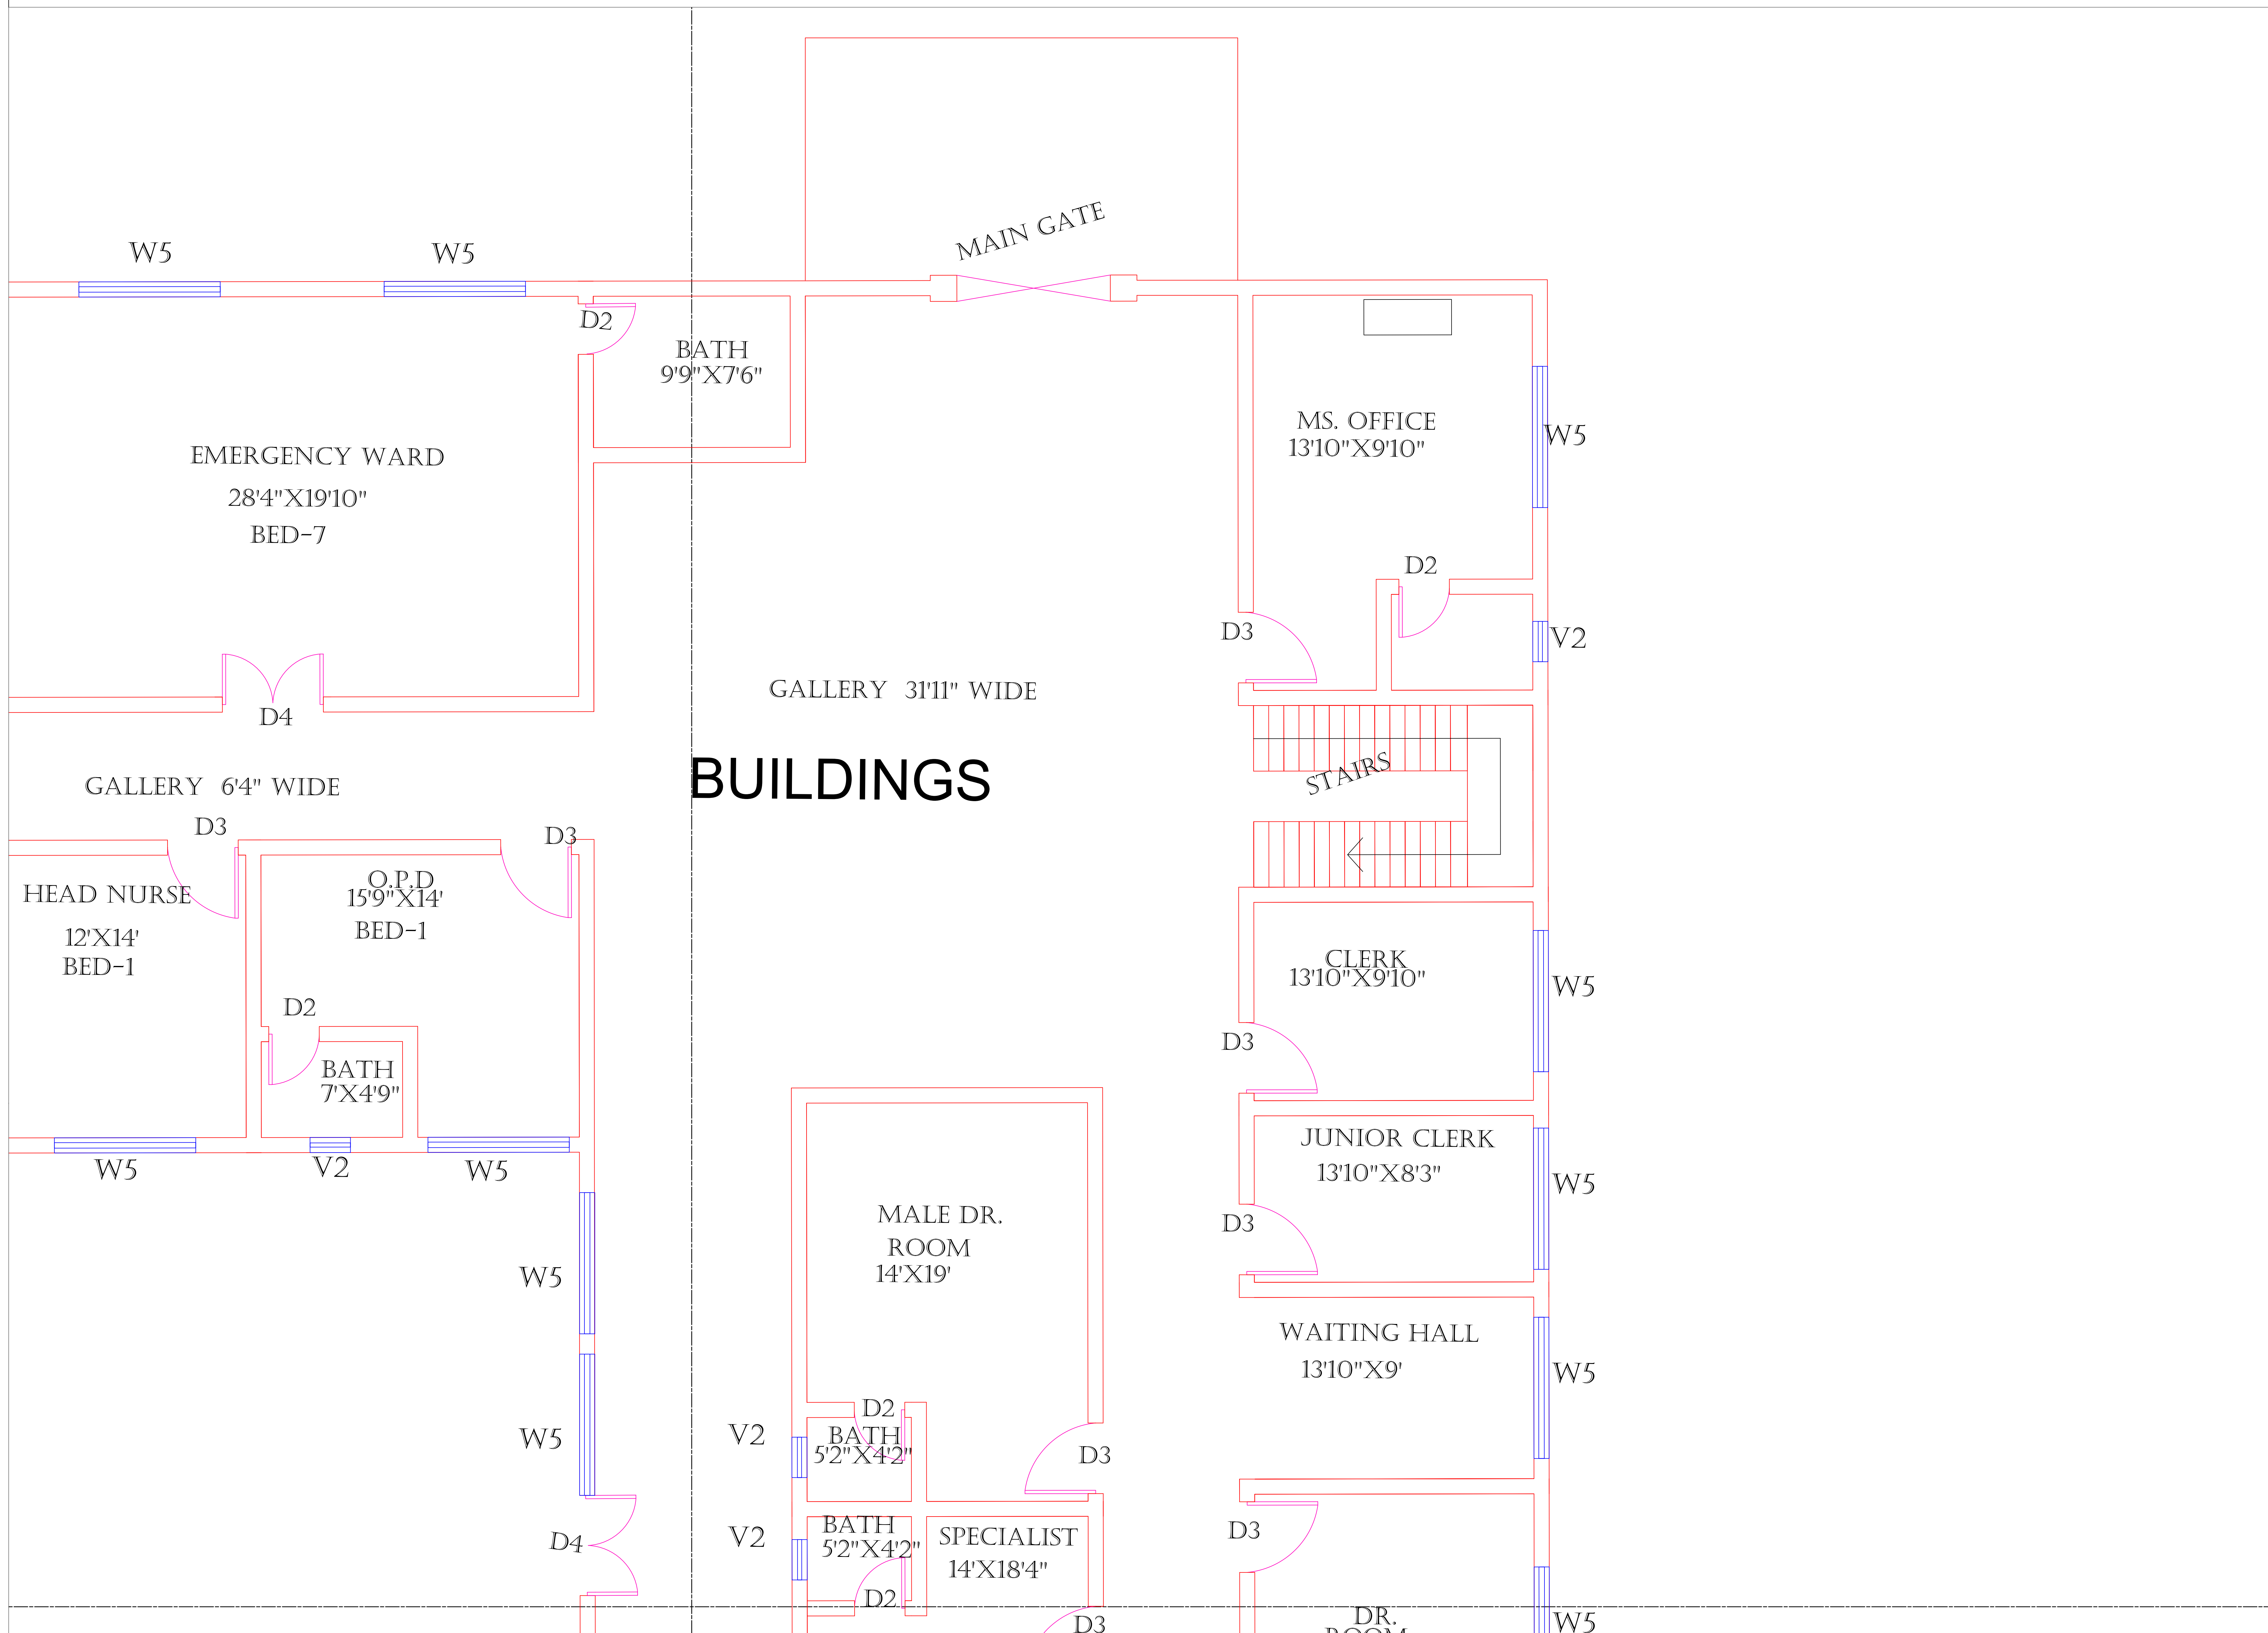

LEGENDS:	
RESIDENTIAL AREA	
ROAD	
WALL	
POWER LINE	
OHT	
TREE	
MANHOLE	
TUBE WELL	
LIGHT POLE	
LAWNS	
EARTHEN AREAS	
ASPHALTS ROADS	
TOUGH PAVERS	
P.C.C /PLINTH PROTECTION	
BOUNDARY WALL	
TAP	
HAND PUMP	
BRICK PAVERS	
AIR CONDITIONER	
TUBE LIGHT	
FAN	
ROOF LIGHT	
BULB	

AREA	
AREA WITHIN BOUNDARY WALL	6640307.6284 SFT
AREA OF CLINICAL BLOCK	3820285.0024 SFT
PLINTH AREA OF BLOCK	1910142.5012 SFT

OPENING SCHEDULE OF DOORS AND WINDOWS					
DOORS	WIDTH	HEIGHT	WINDOWS	WIDTH	HEIGHT
D1	3'-6"	8'-3"	W1	4'-0"	5'-6"
D2	2'-6"	7'-0"	W2	5'-0"	3'-6"
D3	4'-0"	8'-3"	W3	6'-0"	5'-6"
D4	3'-0"	8'-3"	W4	3'-0"	8'-3"
D5			W5	6'-0"	7'-0"
D6			W6	3'-0"	5'-6"
D7			V1	4'-0"	1'-6"
D8			V2	4'-0"	3'-0"
D9					

Client:

**GOVERNMENT OF THE PUNJAB
PRIMARY & SECONDARY
HEALTHCARE DEPARTMENT**

Project:

**CAD MAPPING OF TEHSIL
HEAD QUARTER HOSPITALS,
PUNJAB**

Consultant:

SKAFS CONSULTANT (Pvt.) Limited
ENGINEERING AND ENVIRONMENT CONSULTANT

Drawing Title:

**THQ HASSAN ABDAL
HOSPITAL CLINICAL BLOCK
PART 2**


Authorized By: SKAFS	Reviewed By Co-Team Leader	Scale:
Prepared By: CAD TEAMS	Date: FEB, 2017	

Drawing No.

SKAFS/HASSAN ABDAL /10

CLINICAL BLOCK OF THQ HOSPITAL HASSAN ABDAL

GROUND FLOOR (PART 3)

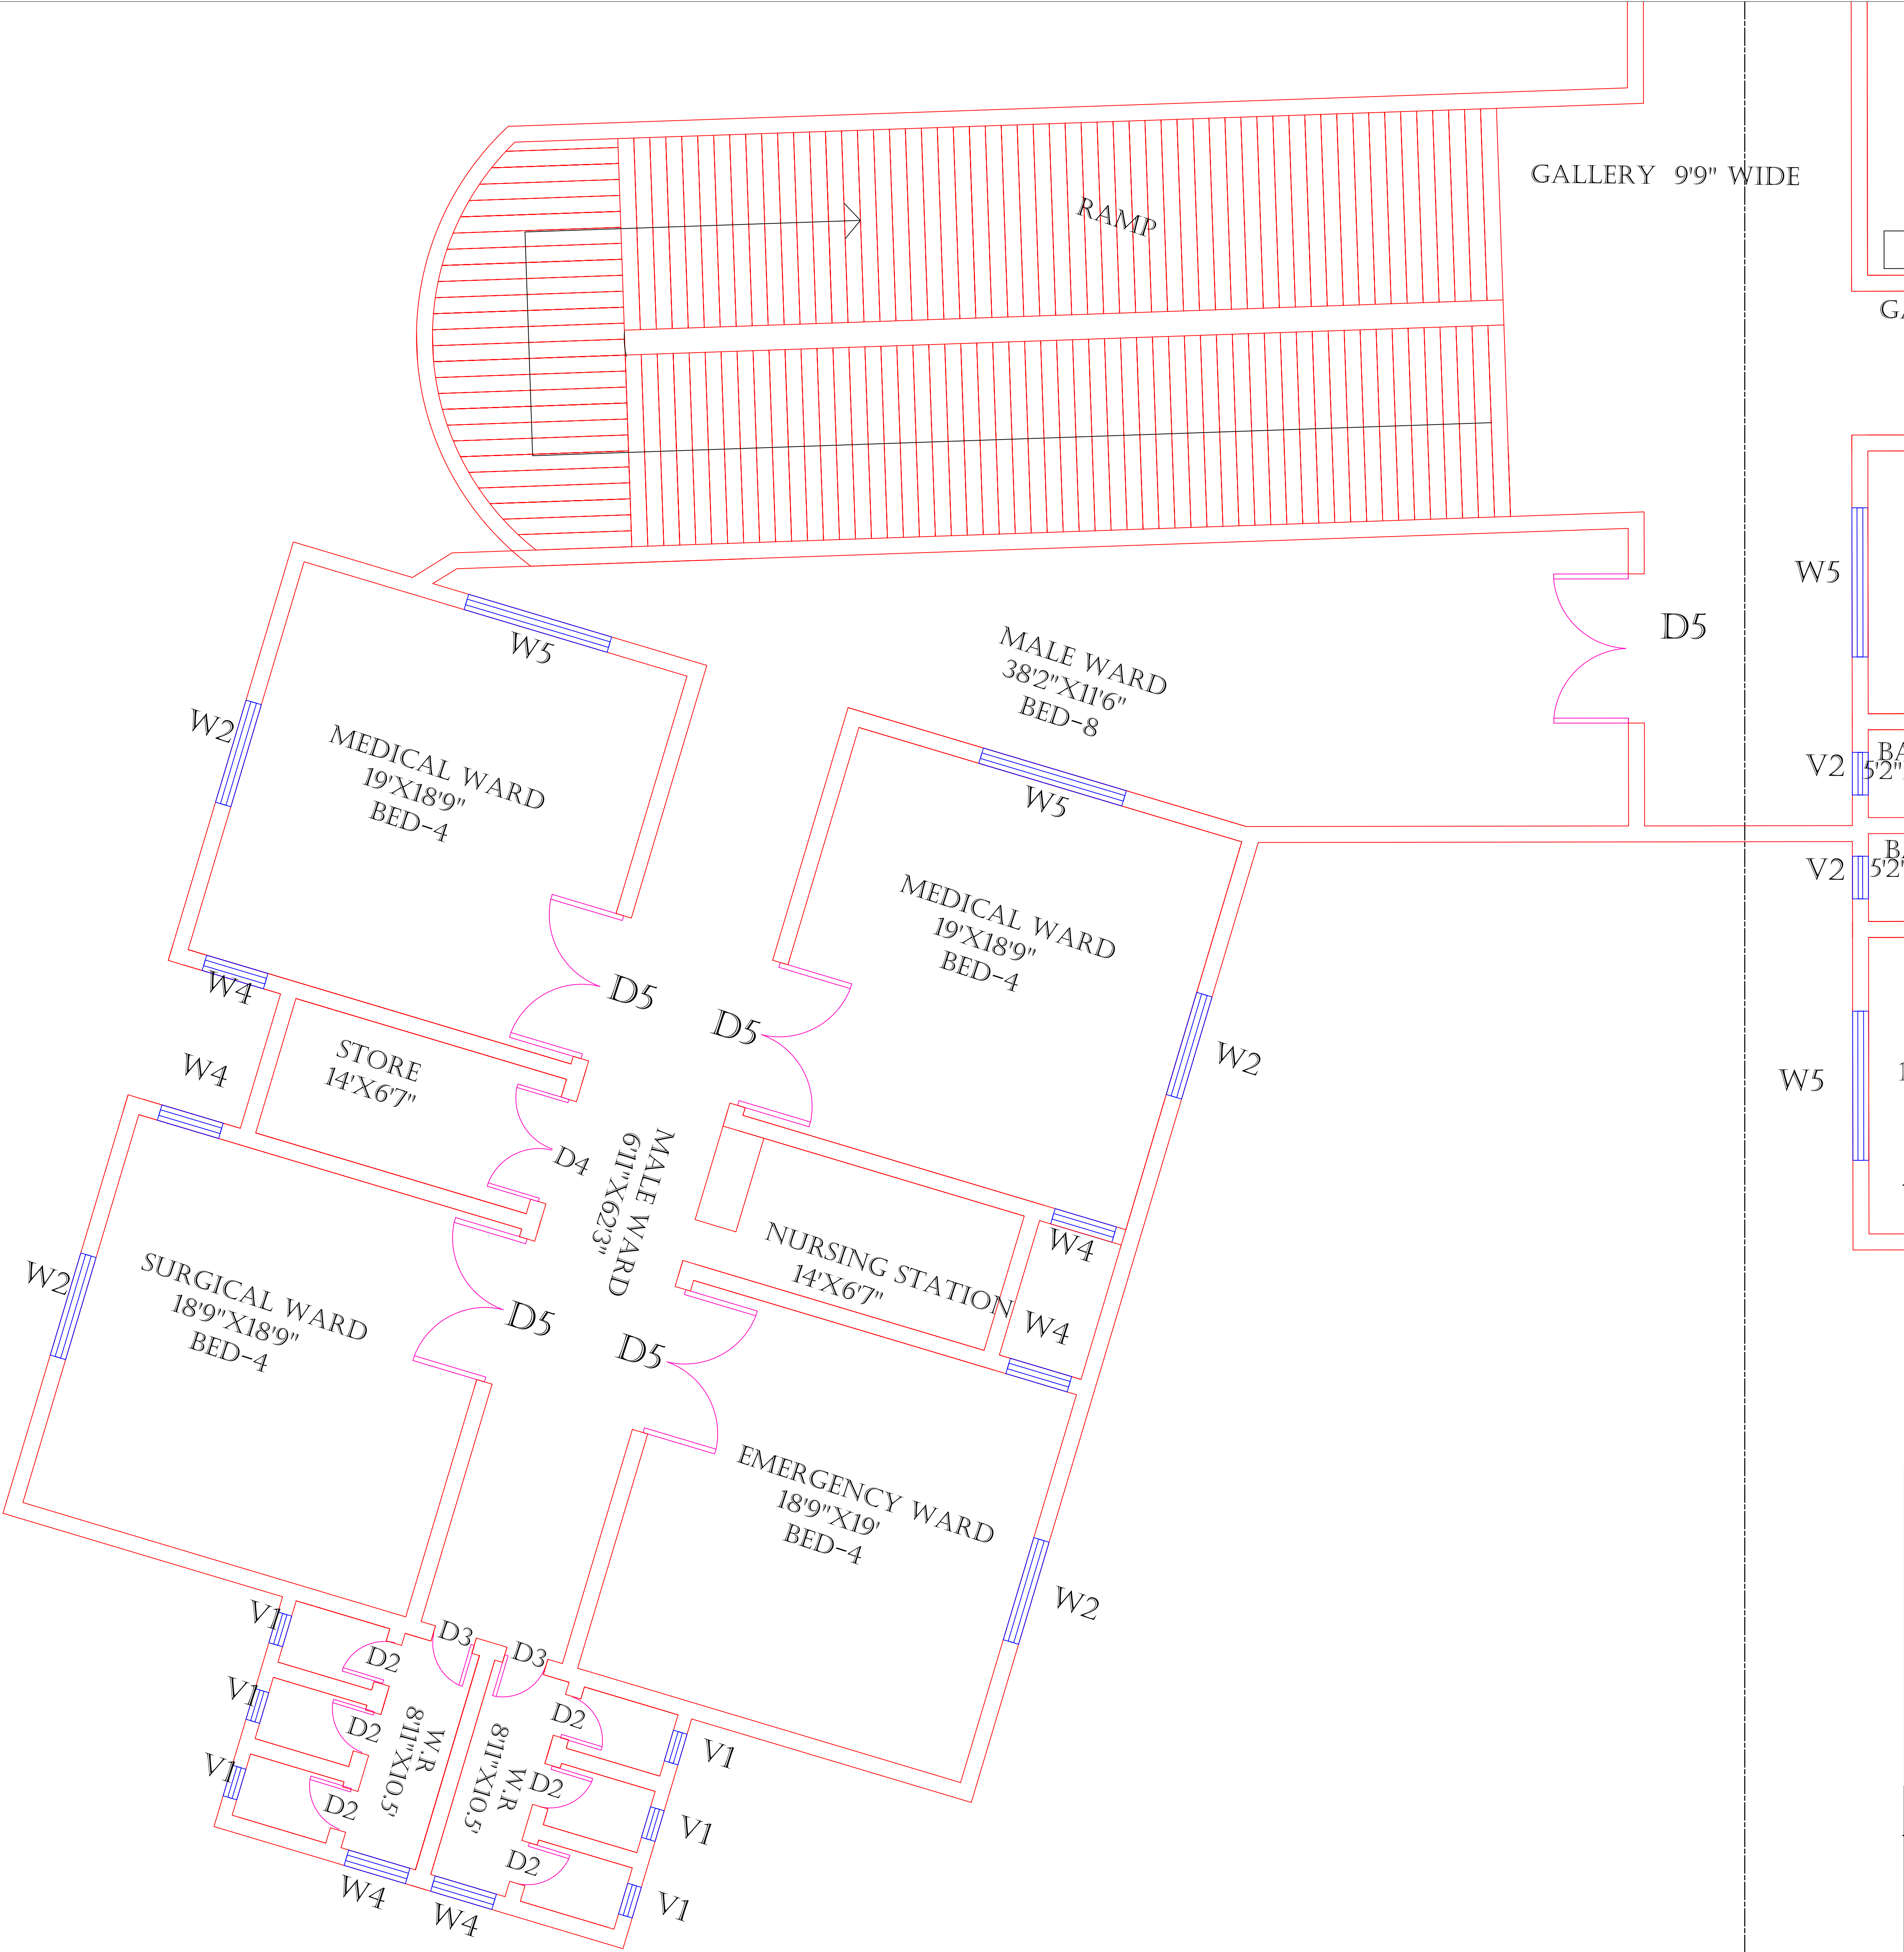

Legends:

RESIDENTIAL AREA	
ROAD	
WALL	
POWER LINE	
OHT	
TREE	
MANHOLE	
TUBE WELL	
LIGHT POLE	
LAWNS	
EARTHEN AREAS	
ASPHALTS ROADS	
TOUGH PAVERS	
P.C.C /PLINTH PROTECTION	
BOUNDARY WALL	
TAP	
HAND PUMP	
BRICK PAVERS	
AIR CONDITIONER	
TUBE LIGHT	
FAN	
ROOF LIGHT	
BULB	

AREA	
AREA WITHIN BOUNDARY WALL	6640307.6284 SFT
AREA OF CLINICAL BLOCK	3820285.0024 SFT
PLINTH AREA OF BLOCK	1910142.5012 SFT

OPENING SCHEDULE OF DOORS AND WINDOWS					
DOORS	WIDTH	HEIGHT	WINDOWS	WIDTH	HEIGHT
D1	3'-6"	8'-3"	W1	4'-0"	5'-6"
D2	2'-6"	7'-0"	W2	5'-0"	3'-6"
D3	4'-0"	8'-3"	W3	6'-0"	5'-6"
D4	3'-0"	8'-3"	W4	3'-0"	8'-3"
D5			W5	6'-0"	7'-0"
D6			W6	3'-0"	5'-6"
D7			V1	4'-0"	1'-6"
D8			V2	4'-0"	3'-0"
D9					

Client:


**GOVERNMENT OF THE PUNJAB
PRIMARY & SECONDARY
HEALTHCARE DEPARTMENT**

Project:

**CAD MAPPING OF TEHSIL
HEAD QUARTER HOSPITALS,
PUNJAB**

Consultant:


SKAFS CONSULTANT (Pvt.) Limited
ENGINEERING AND ENVIRONMENT CONSULTANT

Drawing Title:

**THQ HASSAN ABDAL
HOSPITAL CLINICAL BLOCK
PART 3**

Authorized By: SKAFS	Reviewed By Co-Team Leader	Scale:
Prepared By: CAD TEAMS	Date: FEB, 2017	
Drawing No. SKAFS/HASSAN ABDAL /11		

Legends:	
RESIDENTIAL AREA	
ROAD	
WALL	
POWER LINE	
OHT	
TREE	
MANHOLE	
TUBE WELL	
LIGHT POLE	
LAWNS	
EARTHEN AREAS	
ASPHALTS ROADS	
TOUGH PAVERS	
P.C.C /PLINTH PROTECTION	
BOUNDARY WALL	
TAP	
HAND PUMP	
BRICK PAVERS	
AIR CONDITIONER	
TUBE LIGHT	
FAN	
ROOF LIGHT	
BULB	

AREA	
AREA WITHIN BOUNDARY WALL	6640307.6284 SFT
AREA OF CLINICAL BLOCK	3820285.0024 SFT
PLINTH AREA OF BLOCK	1910142.5012 SFT

OPENING SCHEDULE OF DOORS AND WINDOWS					
DOORS	WIDTH	HEIGHT	WINDOWS	WIDTH	HEIGHT
D1	3'-6"	8'-3"	W1	4'-0"	5'-6"
D2	2'-6"	7'-0"	W2	5'-0"	3'-6"
D3	4'-0"	8'-3"	W3	6'-0"	5'-6"
D4	3'-0"	8'-3"	W4	3'-0"	8'-3"
D5			W5	6'-0"	7'-0"
D6			W6	3'-0"	5'-6"
D7			V1	4'-0"	1'-6"
D8			V2	4'-0"	3'-0"
D9					

Client:

**GOVERNMENT OF THE PUNJAB
PRIMARY & SECONDARY
HEALTHCARE DEPARTMENT**

Project:

CAD MAPPING OF TEHSIL
HEAD QUARTER HOSPITALS,
PUNJAB

Consultant:

SKAFS CONSULTANT (Pvt.) Limited
ENGINEERING AND ENVIRONMENT CONSULTANT

Drawing Title:


THQ HASSAN ABDAL
HOSPITAL CLINICAL BLOCK
PART 4

Authorized By: SKAFS	Reviewed By Co-Team Leader	Scale:
Prepared By: CAD TEAMS	Date: FEB, 2017	

Drawing No. SKAFS/HASSAN ABDAL/12

CLINICAL BLOCK OF THQ HOSPITAL HASSAN ABDAL

FIRST FLOOR (PART 1)

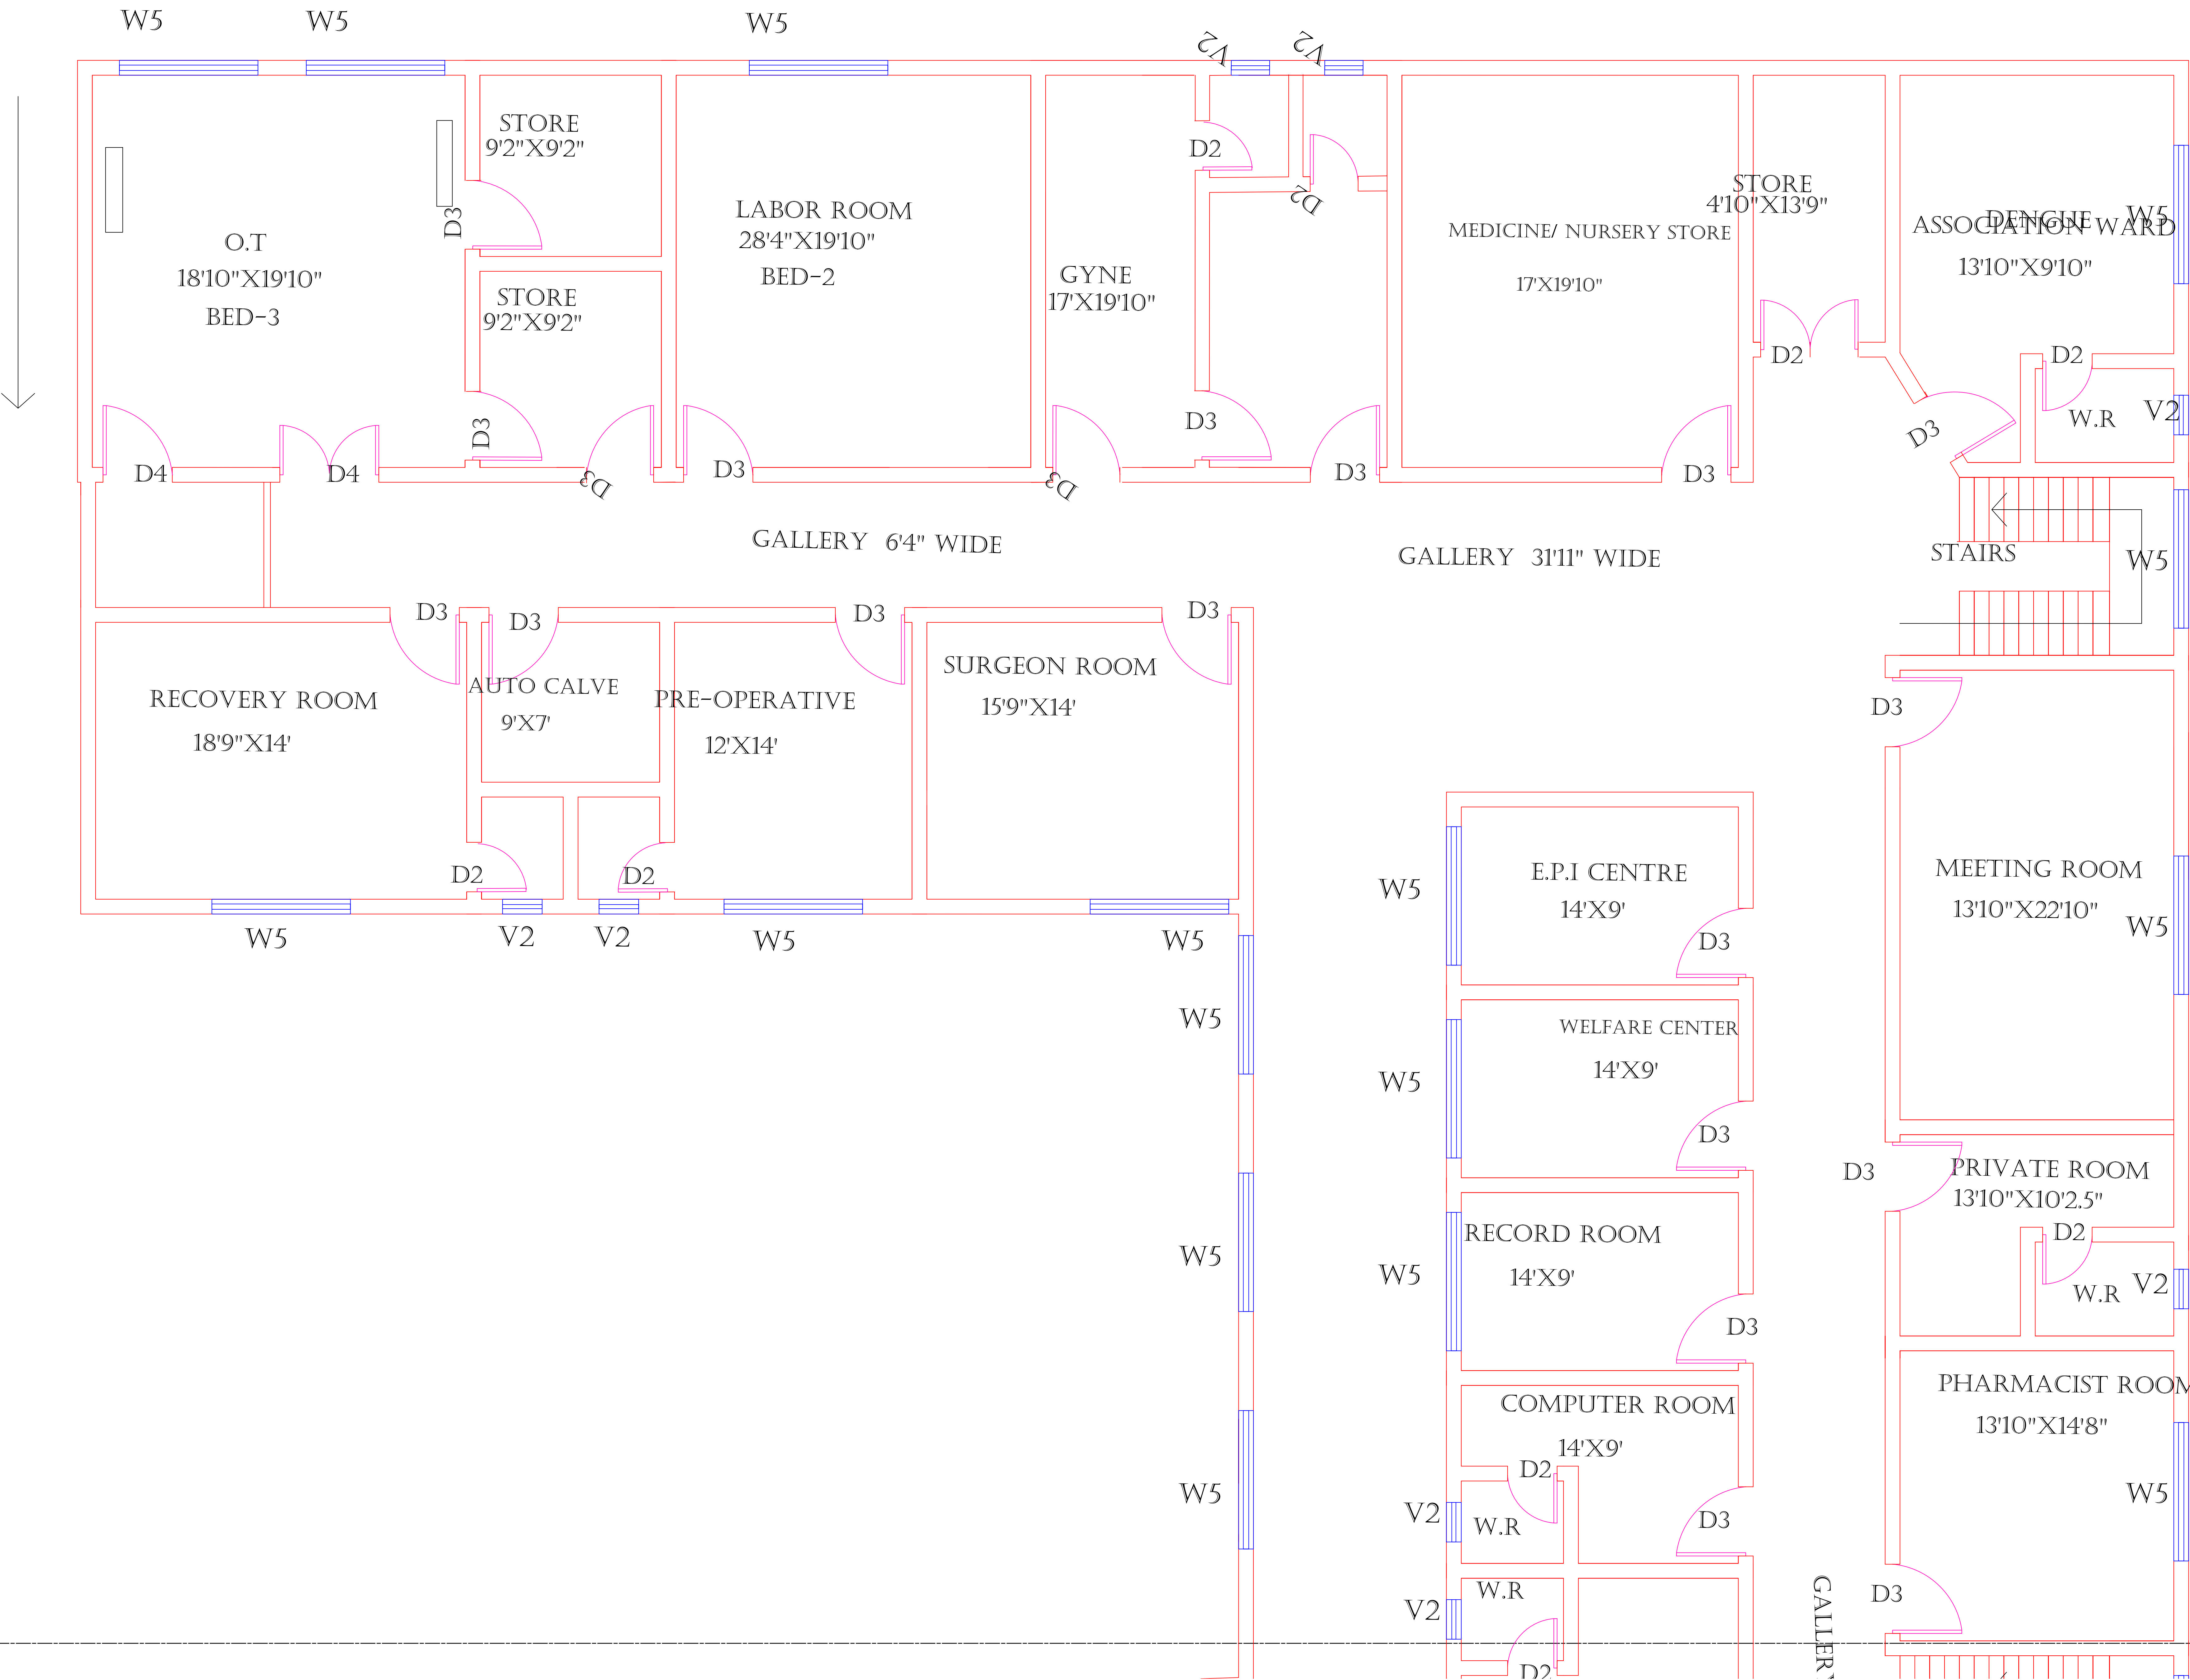

Legends:

RESIDENTIAL AREA	
ROAD	
WALL	
POWER LINE	
OHT	
TREE	
MANHOLE	
TUBE WELL	
LIGHT POLE	
LAWNS	
EARTHEN AREAS	
ASPHALTS ROADS	
TOUGH PAVERS	
P.C.C /PLINTH PROTECTION	
BOUNDARY WALL	
TAP	
HAND PUMP	
BRICK PAVERS	
AIR CONDITIONER	
TUBE LIGHT	
FAN	
ROOF LIGHT	
BULB	

AREA	
AREA WITHIN BOUNDARY WALL	6640307.6284 SFT
AREA OF CLINICAL BLOCK	3820285.0024 SFT
PLINTH AREA OF BLOCK	1910142.5012 SFT

OPENING SCHEDULE OF DOORS AND WINDOWS					
DOORS	WIDTH	HEIGHT	WINDOWS	WIDTH	HEIGHT
D1	3'-6"	8'-3"	W1	4'-0"	5'-6"
D2	2'-6"	7'-0"	W2	5'-0"	3'-6"
D3	4'-0"	8'-3"	W3	6'-0"	5'-6"
D4	3'-0"	8'-3"	W4	3'-0"	8'-3"
D5			W5	6'-0"	7'-0"
D6			W6	3'-0"	5'-6"
D7			V1	4'-0"	1'-6"
D8			V2	4'-0"	3'-0"
D9					

Client:



GOVERNMENT OF THE PUNJAB
PRIMARY & SECONDARY
HEALTHCARE DEPARTMENT

Project:

**CAD MAPPING OF TEHSIL
HEAD QUARTER HOSPITALS,
PUNJAB**

Consultant:



SKAFS CONSULTANT (Pvt.) Limited
ENGINEERING AND ENVIRONMENT CONSULTANT

Drawing Title:


**THQ HASSAN ABDAL
HOSPITAL CLINICAL BLOCK
PART 4**

Authorized By: SKAFS	Reviewed By Co-Team Leader	Scale:
Prepared By: CAD TEAMS	Date: FEB, 2017	

Drawing No. **SKAFS/HASSAN ABDAL /13**

CLINICAL BLOCK OF THQ HOSPITAL HASSAN ABDAL

FIRST FLOOR (PART 2)

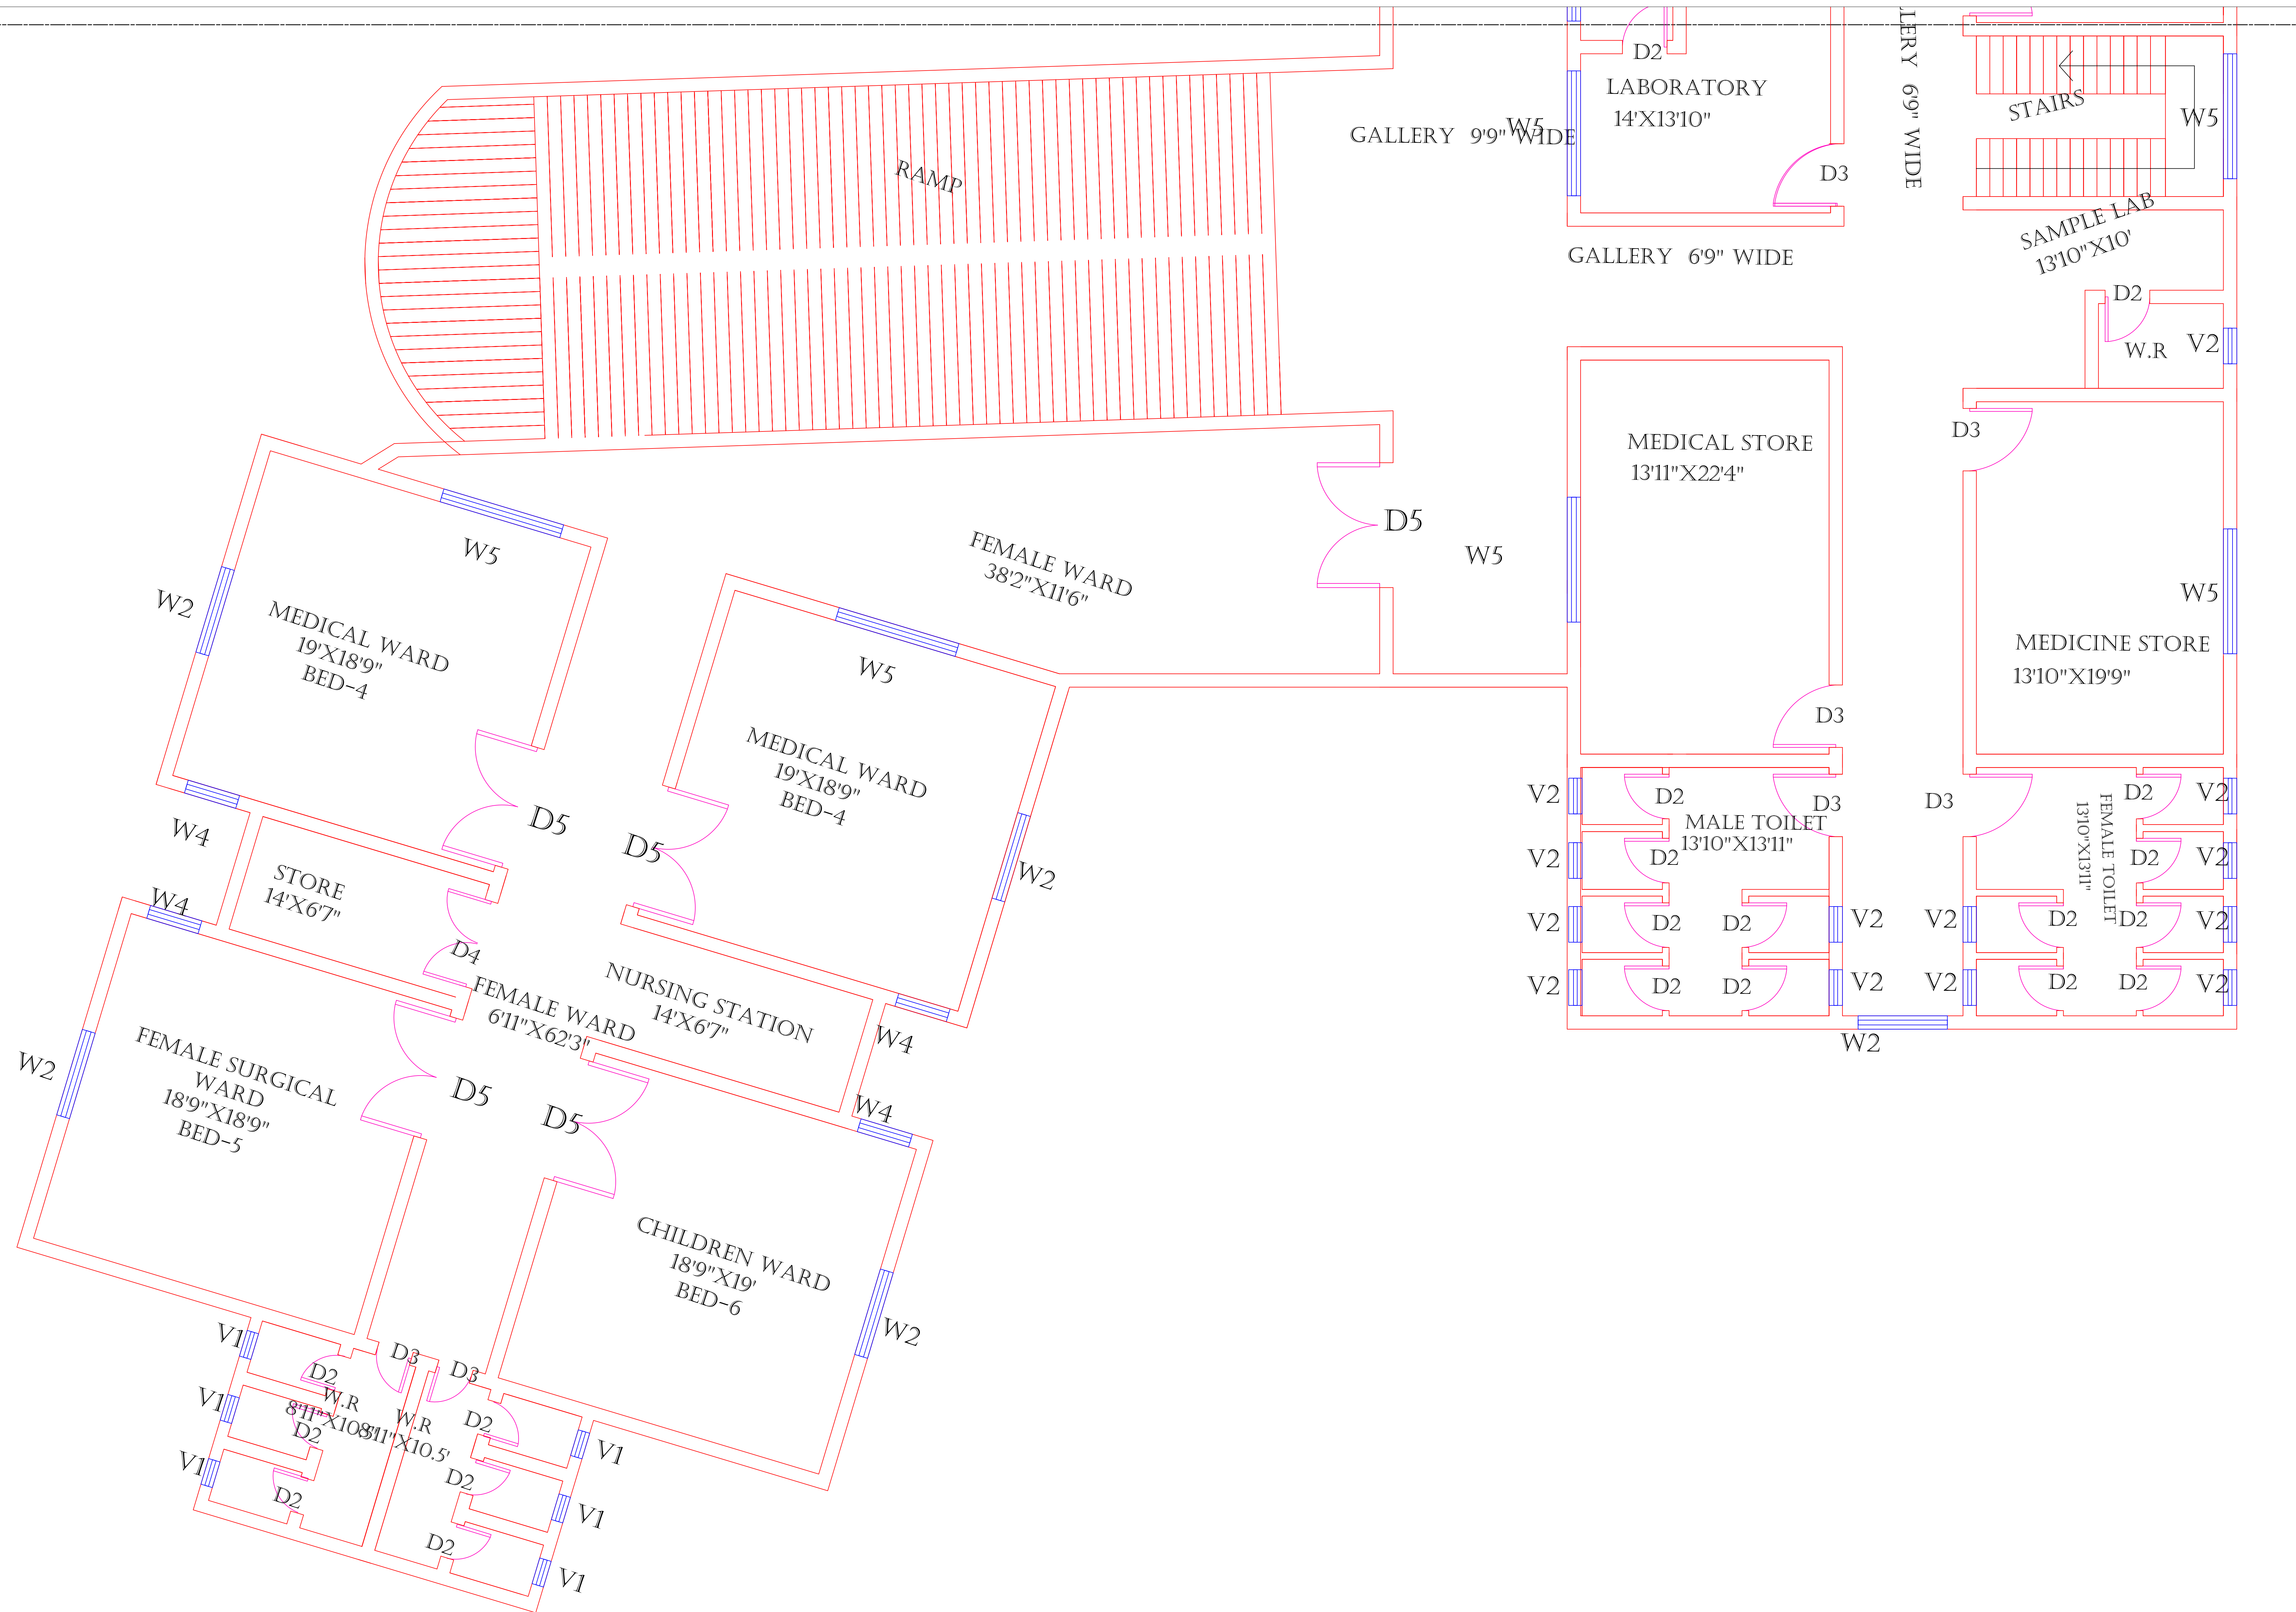

Legends:

RESIDENTIAL AREA	
ROAD	
WALL	
POWER LINE	
OHT	
TREE	
MANHOLE	
TUBE WELL	
LIGHT POLE	
LAWNS	
EARTHEN AREAS	
ASPHALTS ROADS	
TOUGH PAVERS	
P.C.C /PLINTH PROTECTION	
BOUNDARY WALL	
TAP	
HAND PUMP	
BRICK PAVERS	
AIR CONDITIONER	
TUBE LIGHT	
FAN	
ROOF LIGHT	
BULB	

AREA					
AREA WITHIN BOUNDARY WALL		6640307.6284 SFT			
AREA OF CLINICAL BLOCK		3820285.0024 SFT			
PLINTH AREA OF BLOCK		1910142.5012 SFT			

OPENING SCHEDULE OF DOORS AND WINDOWS					
DOORS	WIDTH	HEIGHT	WINDOWS	WIDTH	HEIGHT
D1	3'-6"	8'-3"	W1	4'-0"	5'-6"
D2	2'-6"	7'-0"	W2	5'-0"	3'-6"
D3	4'-0"	8'-3"	W3	6'-0"	5'-6"
D4	3'-0"	8'-3"	W4	3'-0"	8'-3"
D5			W5	6'-0"	7'-0"
D6			W6	3'-0"	5'-6"
D7			V1	4'-0"	1'-6"
D8			V2	4'-0"	3'-0"
D9					

Client:

GOVERNMENT OF THE PUNJAB
PRIMARY & SECONDARY
HEALTHCARE DEPARTMENT

Project:

CAD MAPPING OF TEHSIL
HEAD QUARTER HOSPITALS,
PUNJAB

Consultant:

SKAFS CONSULTANT (Pvt.) Limited
ENGINEERING AND ENVIRONMENT CONSULTANT


Drawing Title:

THQ HASSAN ABDAL
HOSPITAL CLINICAL BLOCK
PART 4

Authorized By: SKAFS	Reviewed By Co-Team Leader	Scale:
Prepared By: CAD TEAMS	Date: FEB, 2017	
Drawing No. SKAFS/HASSAN ABDAL/14		

ELECTRICAL LAYOUT PLAN OF THQ HOSPITAL HASSAN ABDAL

GROUND FLOOR

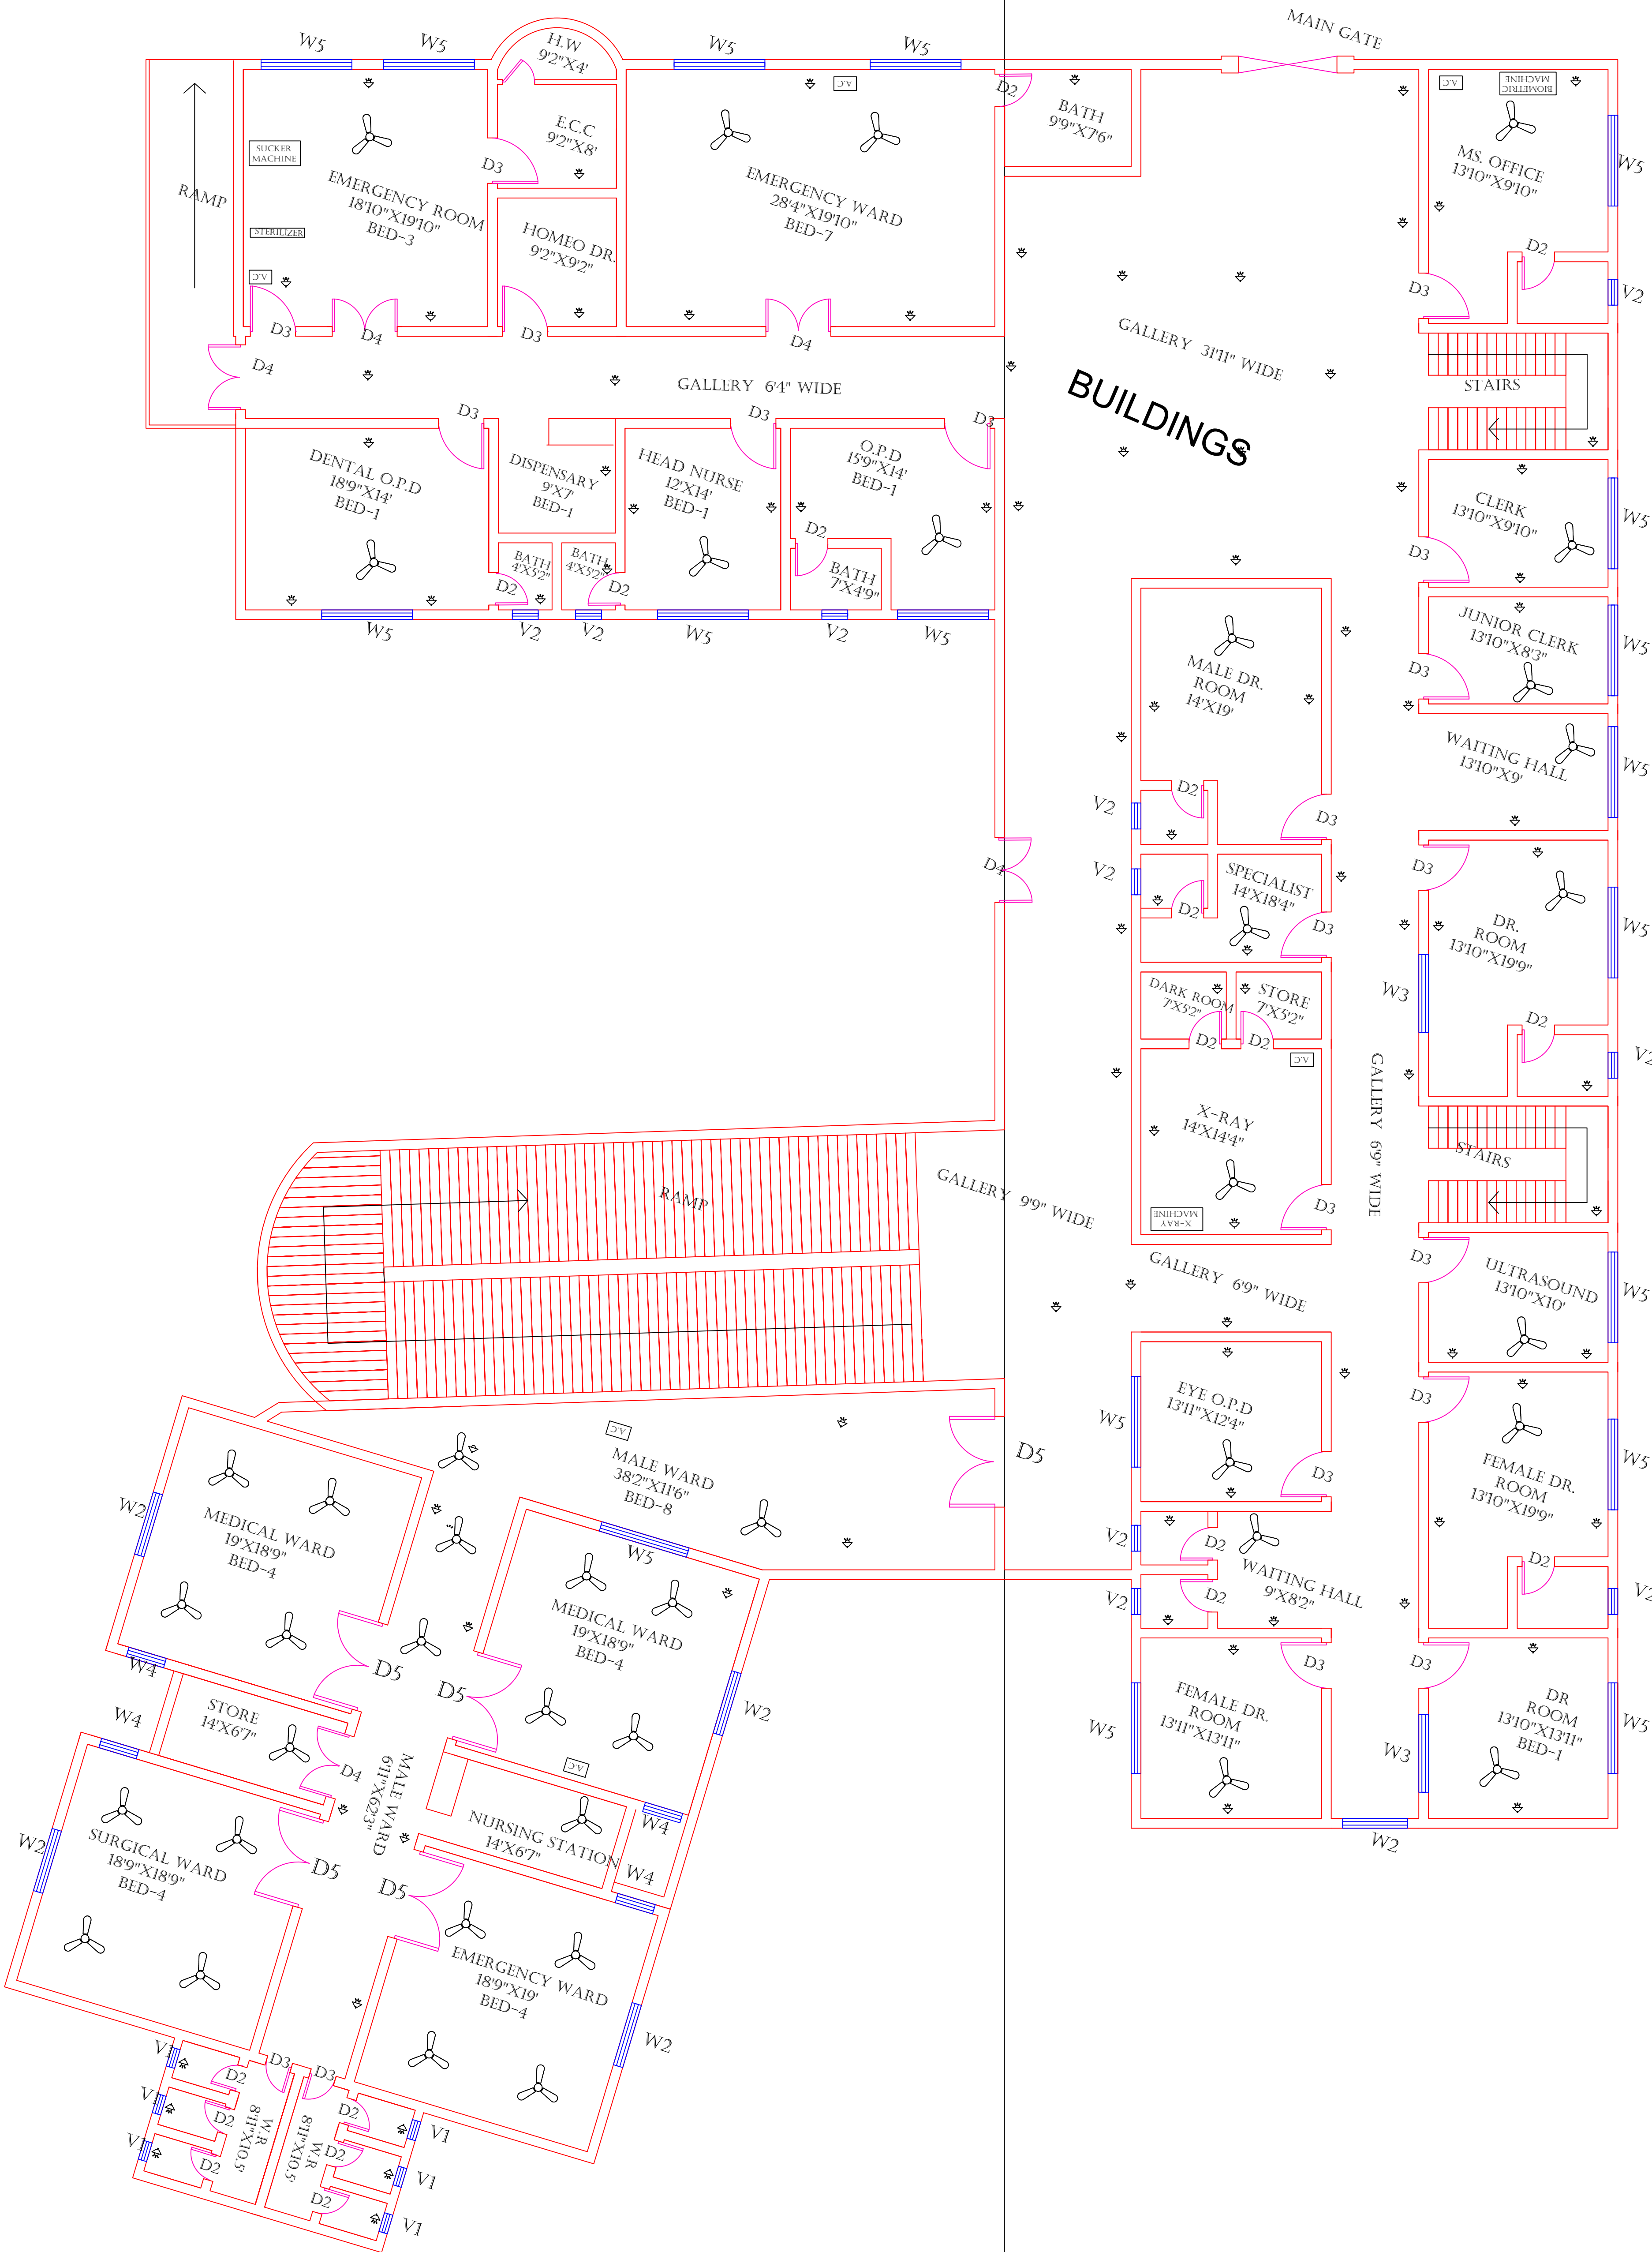

Legends:

RESIDENTIAL AREA	
ROAD	
WALL	
POWER LINE	
OHT	
TREE	
MANHOLE	
TUBE WELL	
LIGHT POLE	
LAWNS	
EARTHEN AREAS	
ASPHALTS ROADS	
TOUGH PAVERS	
P.C.C /PLINTH PROTECTION	
BOUNDARY WALL	
TAP	
HAND PUMP	
BRICK PAVERS	
AIR CONDITIONER	
TUBE LIGHT	
FAN	
ROOF LIGHT	
BULB	

AREA	
AREA WITHIN BOUNDARY WALL	6640307.6284 SFT
AREA OF CLINICAL BLOCK	3820285.0024 SFT
PLINTH AREA OF BLOCK	1910142.5012 SFT

OPENING SCHEDULE OF DOORS AND WINDOWS					
DOORS	WIDTH	HEIGHT	WINDOWS	WIDTH	HEIGHT
D1	3'-6"	8'-3"	W1	4'-0"	5'-6"
D2	2'-6"	7'-0"	W2	5'-0"	3'-6"
D3	4'-0"	8'-3"	W3	6'-0"	5'-6"
D4	3'-0"	8'-3"	W4	3'-0"	8'-3"
D5			W5	6'-0"	7'-0"
D6			W6	3'-0"	5'-6"
D7			V1	4'-0"	1'-6"
D8			V2	4'-0"	3'-0"
D9					

Client:

GOVERNMENT OF THE PUNJAB
PRIMARY & SECONDARY
HEALTHCARE DEPARTMENT

Project:

CAD MAPPING OF TEHSIL
HEAD QUARTER HOSPITALS,
PUNJAB

Consultant:

SKAFS CONSULTANT (Pvt.) Limited
ENGINEERING AND ENVIRONMENT CONSULTANT

Drawing Title:


THQ HASSAN ABDAL
ELECTRICAL LAYOUT
GROUND FLOOR

Authorized By: SKAFS	Reviewed By Co-Team Leader	Scale:
Prepared By: CAD TEAMS	Date: FEB, 2017	
Drawing No.		

SKAFS/HASSAN ABDAL /15

ELECTRICAL LAYOUT PLAN OF THQ HOSPITAL HASSAN ABDAL

FIRST FLOOR

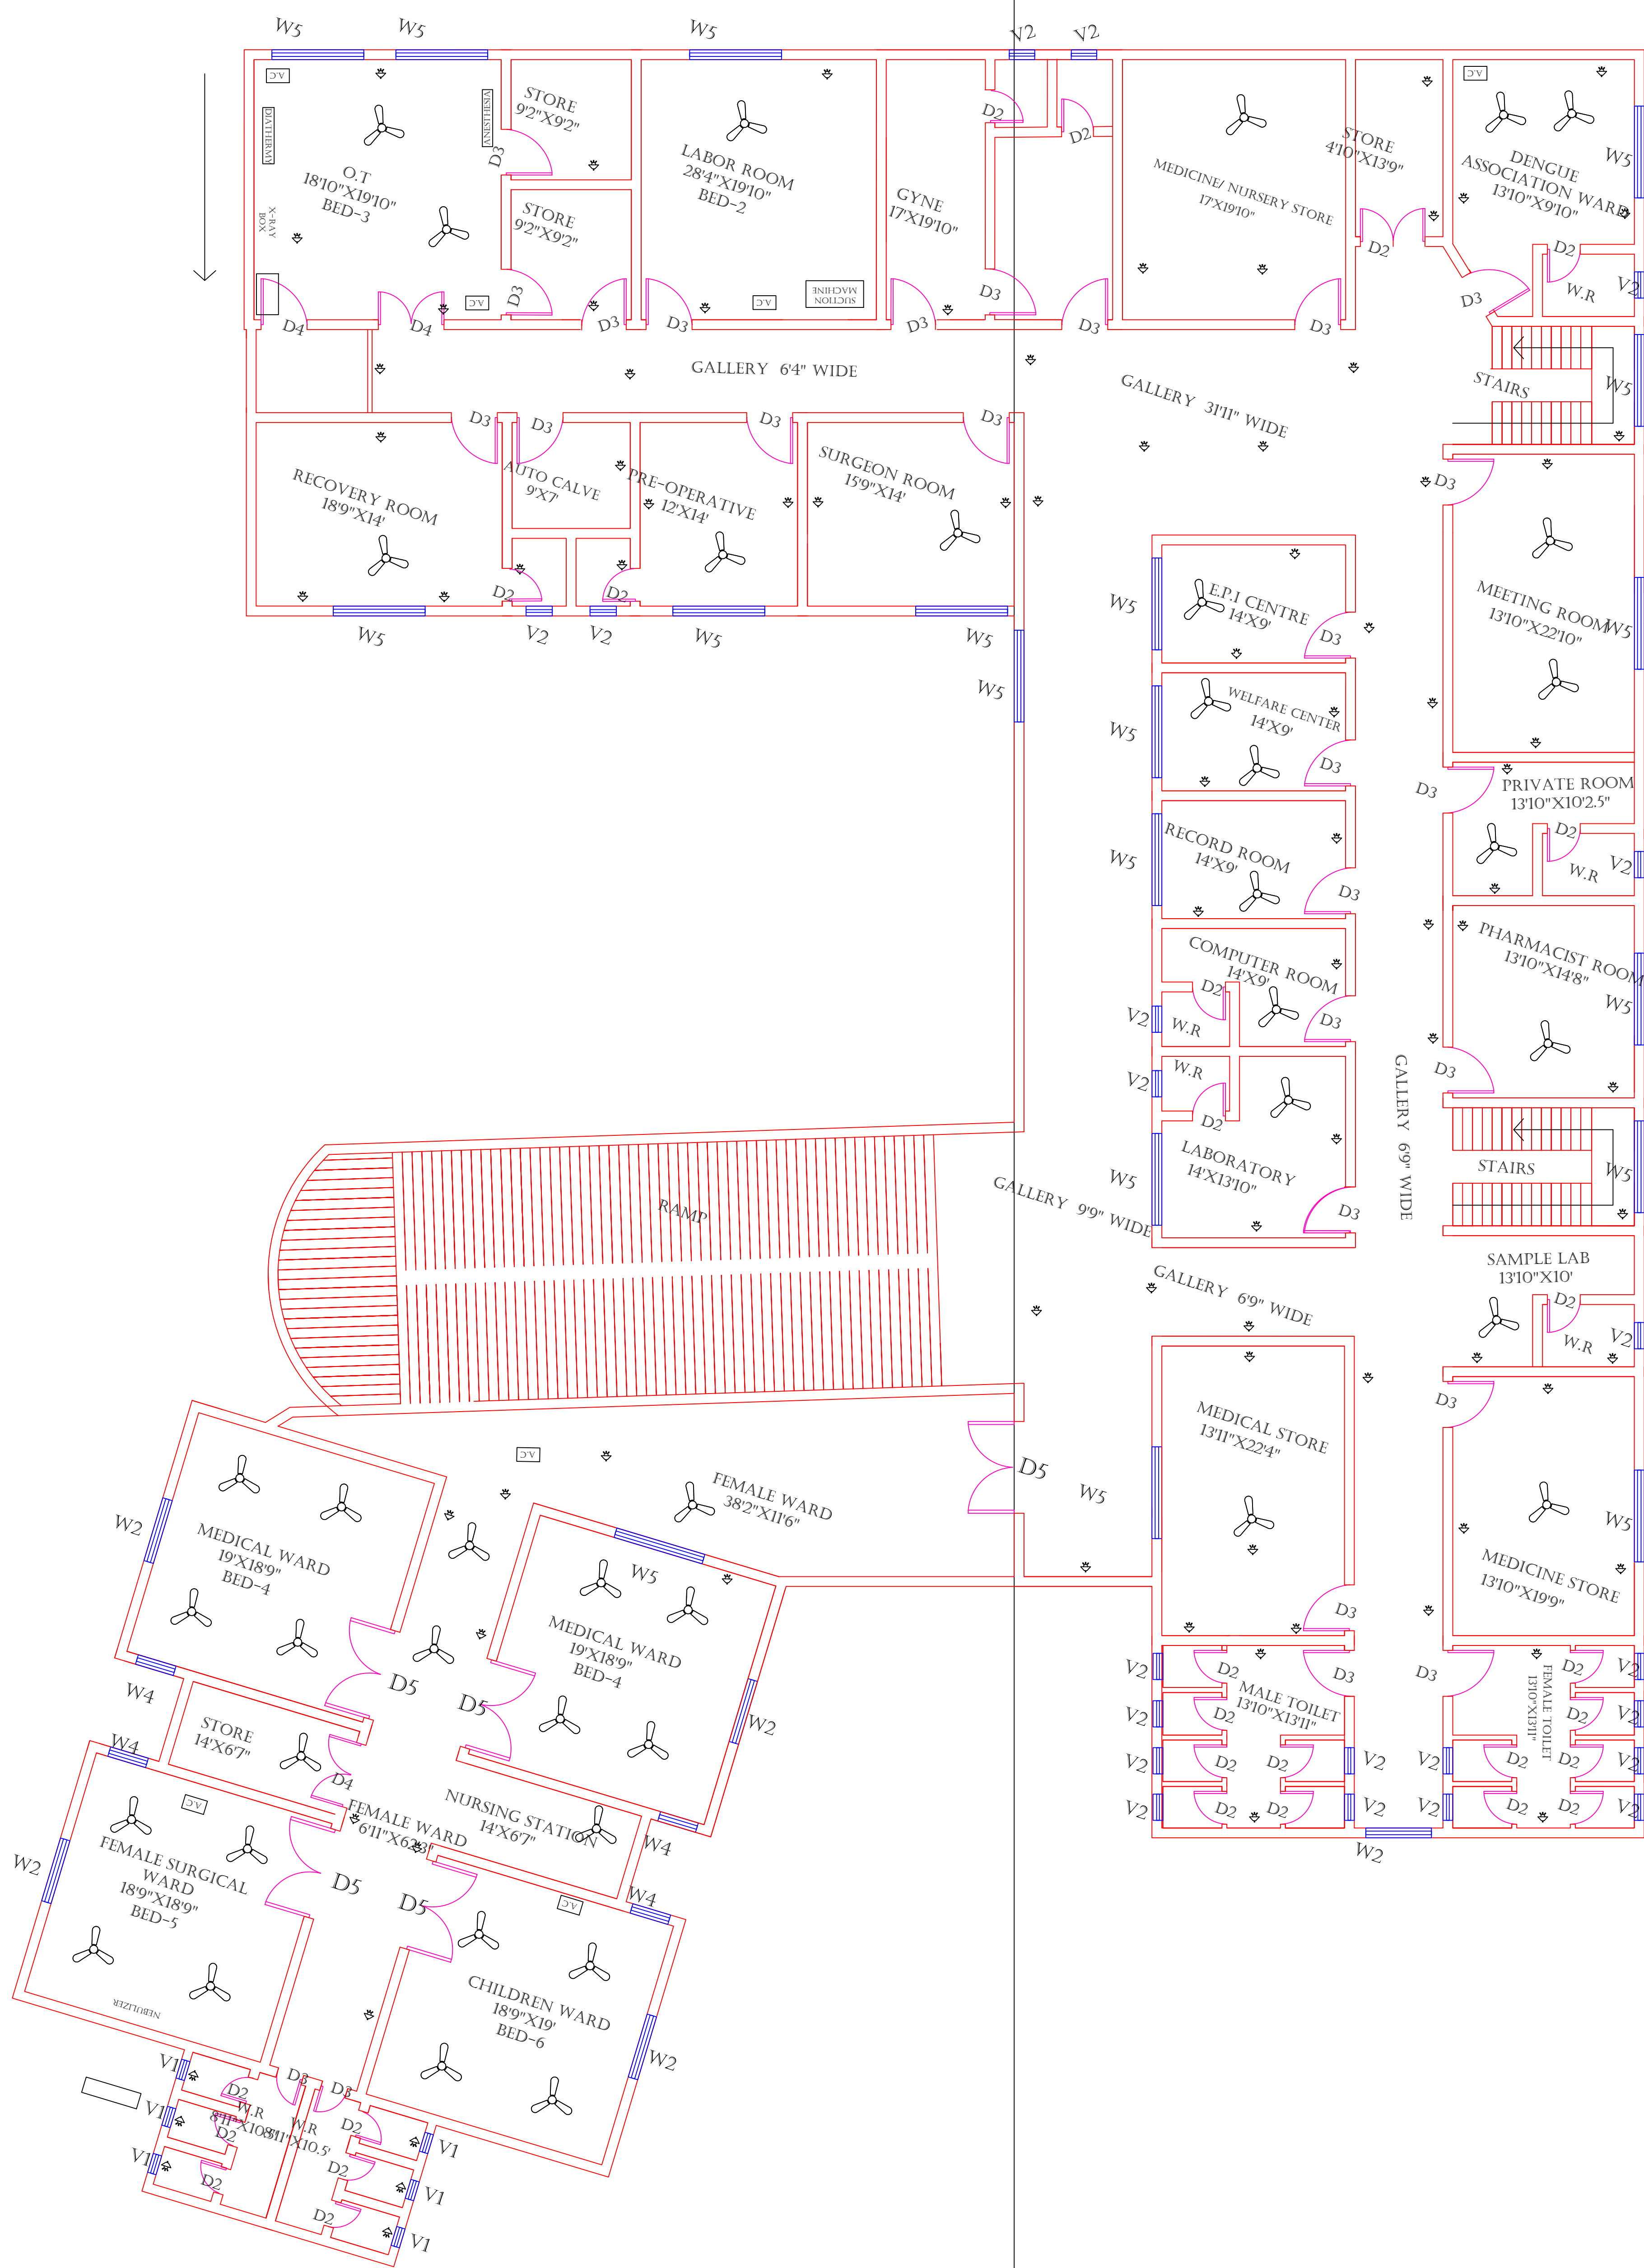

Legends:

RESIDENTIAL AREA	
ROAD	
WALL	
POWER LINE	
OHT	
TREE	
MANHOLE	
TUBE WELL	
LIGHT POLE	
LAWNS	
EARTHEN AREAS	
ASPHALTS ROADS	
TOUGH PAVERS	
P.C.C /PLINTH PROTECTION	
BOUNDARY WALL	
TAP	
HAND PUMP	
BRICK PAVERS	
AIR CONDITIONER	
TUBE LIGHT	
FAN	
ROOF LIGHT	
BULB	

AREA	
AREA WITHIN BOUNDARY WALL	6640307.6284 SFT
AREA OF CLINICAL BLOCK	3820285.0024 SFT
PLINTH AREA OF BLOCK	1910142.5012 SFT

OPENING SCHEDULE OF DOORS AND WINDOWS					
DOORS	WIDTH	HEIGHT	WINDOWS	WIDTH	HEIGHT
D1	3'-6"	8'-3"	W1	4'-0"	5'-6"
D2	2'-6"	7'-0"	W2	5'-0"	3'-6"
D3	4'-0"	8'-3"	W3	6'-0"	5'-6"
D4	3'-0"	8'-3"	W4	3'-0"	8'-3"
D5			W5	6'-0"	7'-0"
D6			W6	3'-0"	5'-6"
D7			V1	4'-0"	1'-6"
D8			V2	4'-0"	3'-0"
D9					

Client:

GOVERNMENT OF THE PUNJAB
PRIMARY & SECONDARY
HEALTHCARE DEPARTMENT

Project:

CAD MAPPING OF TEHSIL
HEAD QUARTER HOSPITALS,
PUNJAB

Consultant:

SKAFS CONSULTANT (Pvt.) Limited
ENGINEERING AND ENVIRONMENT CONSULTANT

Drawing Title:

THQ HASSAN ABDAL
ELECTRICAL LAYOUT
FIRST FLOOR

Authorized By: SKAFS	Reviewed By Co-Team Leader	Scale:
Prepared By: CAD TEAMS	Date: FEB, 2017	
Drawing No. SKAFS/HASSAN ABDAL /16		