

MASTER PLAN OF THQ HOSPITAL KHARIAN

PART 1

PART 2

PART 3

PART 4



Legends:

Residential Area	
Road	
Wall	
Power Line	
OHT	
Tree	
Man Hole	
Tube Well	
Light Pole	
Lawns	
Earthen Areas	
Asphalts Roads	
Tough Pavers	
P.C.C / Plinth Protection	
Boundary Wall	
Brick Pavers / Soling	
Drain	
Tap	
Hand Pump	
Air Conditioner	
Tube Light	
Fan	
Roof Light	
Bulb	

AREA					
AREA WITHIN BOUNDARY WALL		369553.48 Sft			
AREA OF CLINICAL BLOCK		46017.03 Sft			
PLINTH AREA OF BLOCK		37462.35 Sft			

OPENING SCHEDULE OF DOORS AND WINDOWS					
DOORS	WIDTH	HEIGHT	WINDOWS	WIDTH	HEIGHT
D1	3'-6"	7'-0"	W1	4'-0"	4'-0"
D2	4'-0"	7'-0"	W2	6'-0"	6'-0"
D4	2'-6"	7'-0"			


Project:
**CAD MAPPING OF TEHSIL
HEAD QUARTER HOSPITALS,
PUNJAB**

Client: GOVERNMENT OF THE PUNJAB PRIMARY & SECONDARY HEALTHCARE DEPARTMENT	Consultant: SKAFS CONSULTANT (Pvt.) Limited ENGINEERING AND ENVIRONMENT CONSULTANT
---	--

Drawing Title: **THQ KHARIAN
HOSPITAL MASTER PLAN**

Drawing No. **SKAFS/KHARIAN /03**

An aerial photograph of a city block. A pink polygonal boundary is drawn over the image, enclosing a central area. A blue line runs diagonally across the block, starting from the top right and ending near the bottom left. The block contains various buildings, streets, and green spaces.

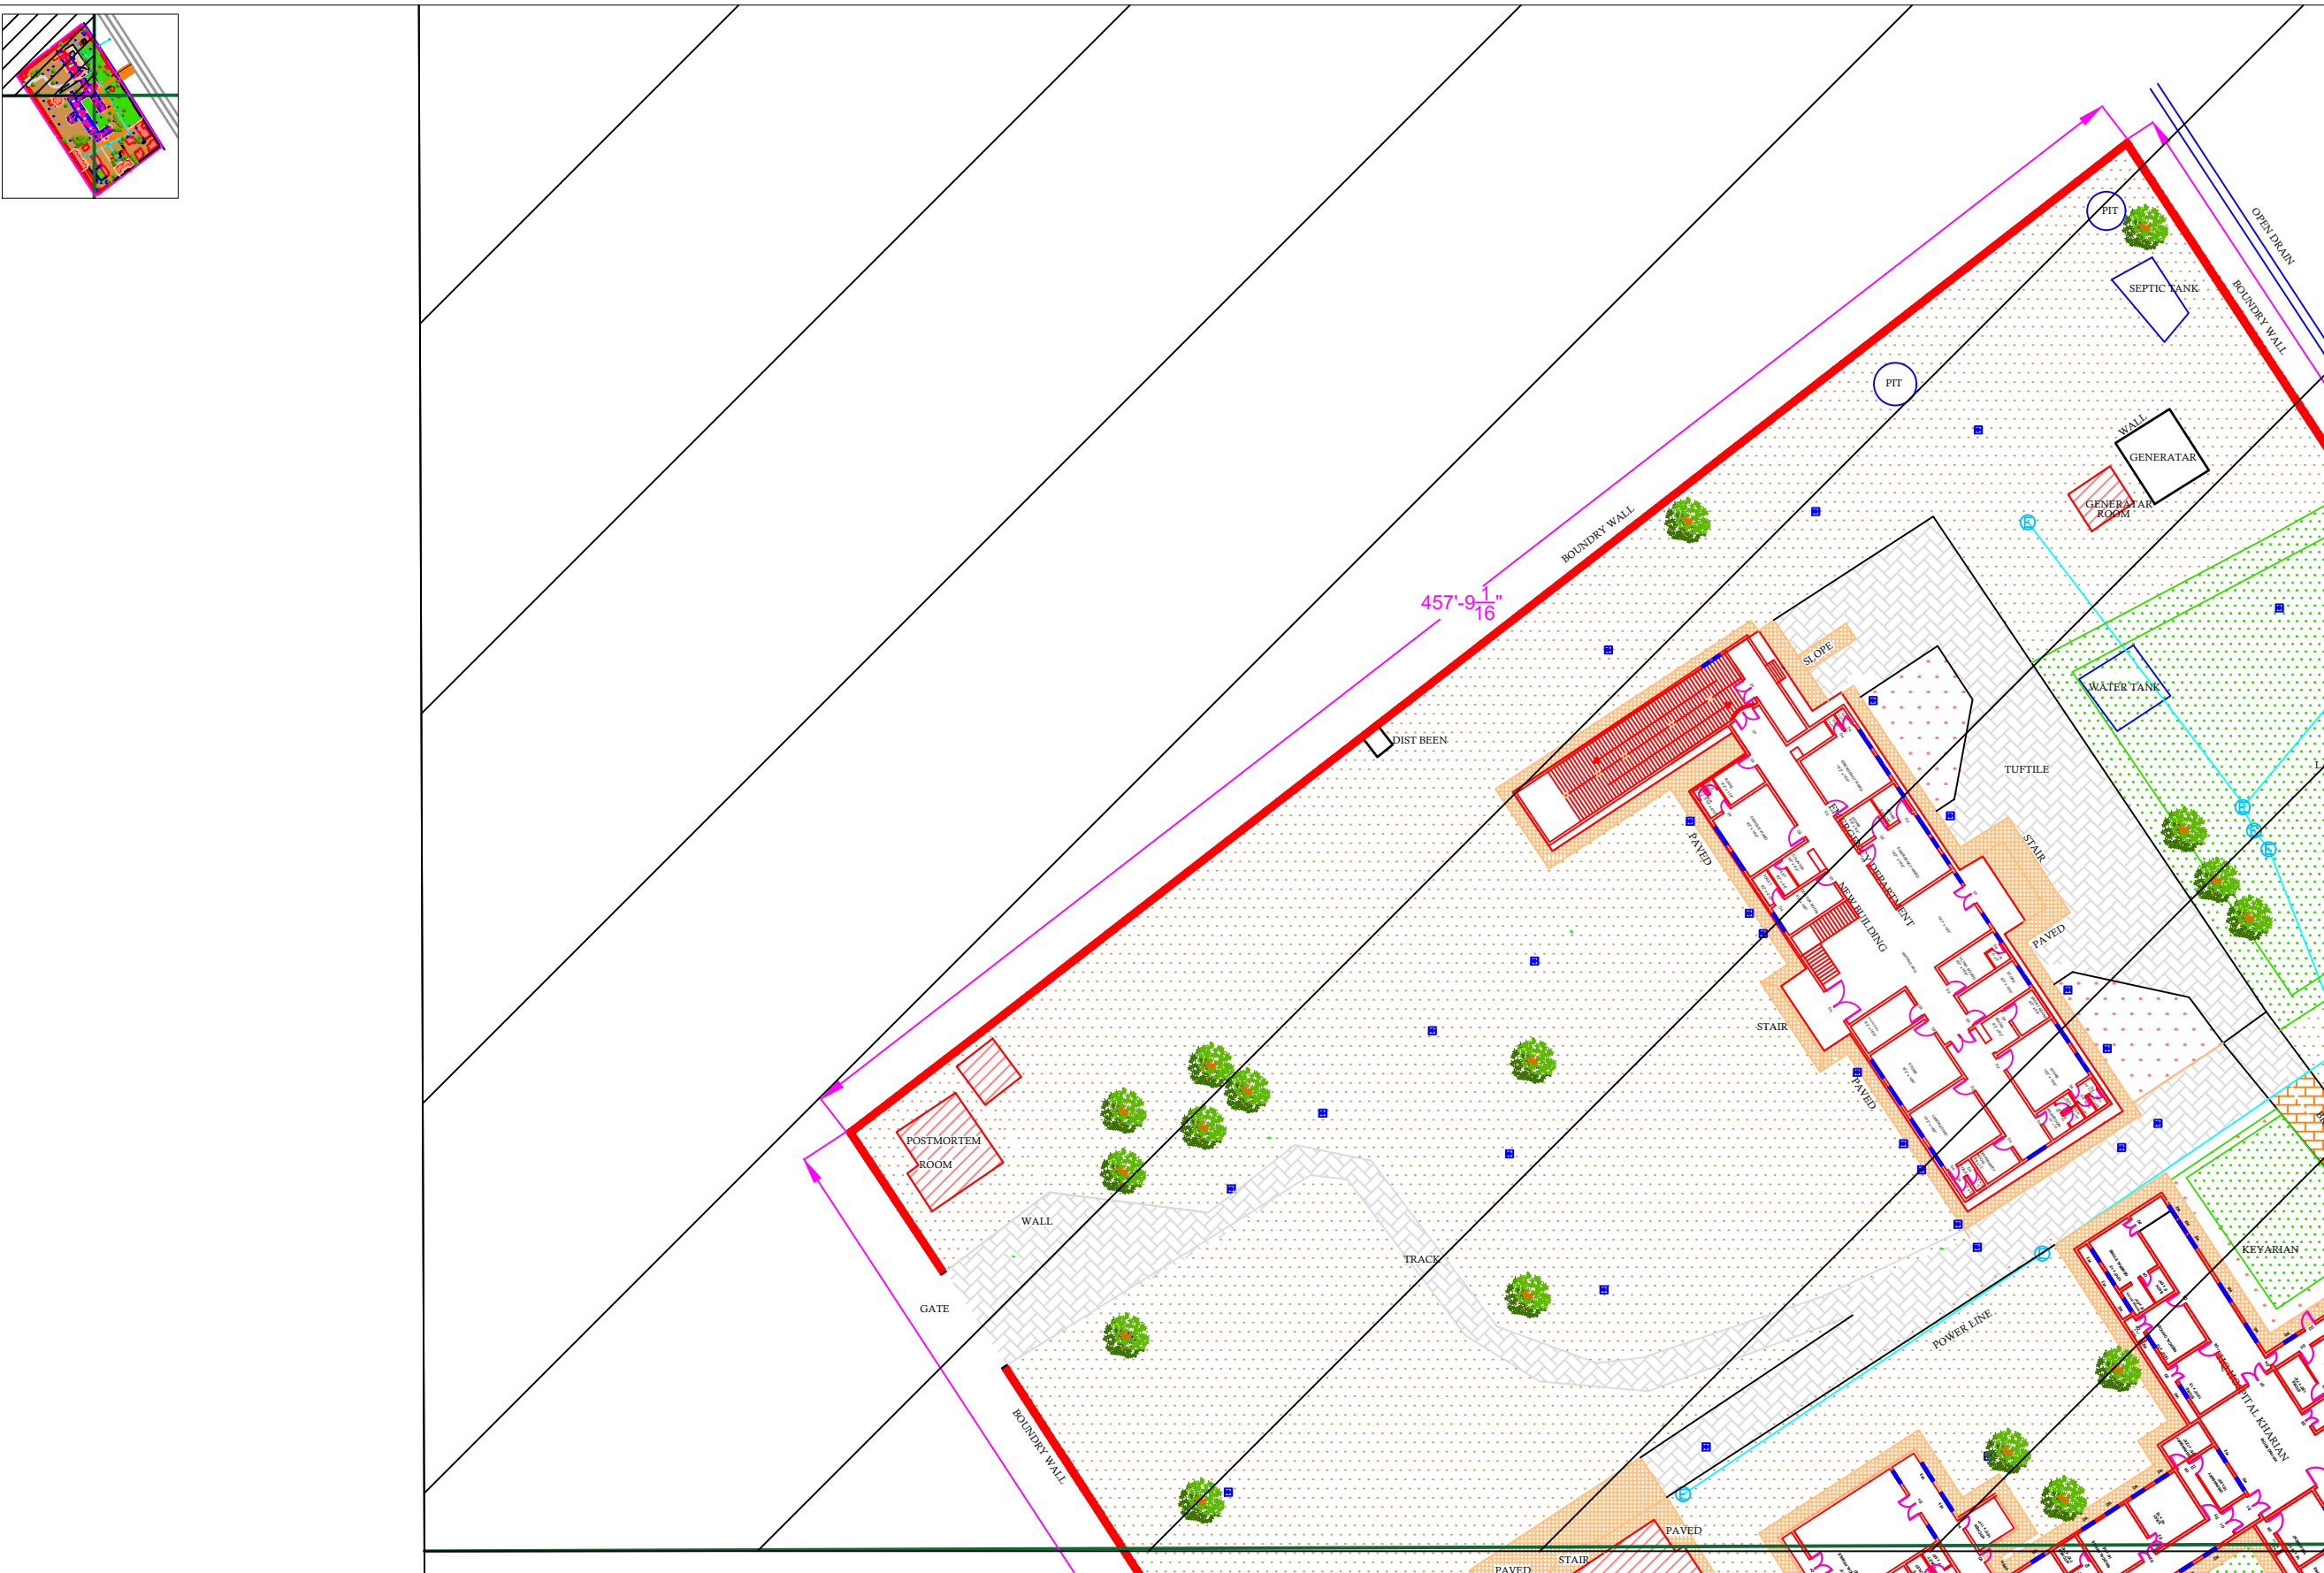

Residential Area	
Road	
Wall	
Power Line	
OHT	
Tree	
Man Hole	
Tube Well	
Light Pole	
Lawns	
Earthen Areas	
Asphalts Roads	
Tough Pavers	
P.C.C / Plinth Protection	
Boundary Wall	
Brick Pavers / Soling	
Drain	
Tap	
Hand Pump	
Air Conditioner	
Tube Light	
Fan	
Roof Light	
Bulb	

AREA	
AREA WITHIN BOUNDARY WALL	369553.48 Sft
AREA OF CLINICAL BLOCK	46017.03 Sft
PLINTH AREA OF BLOCK	37462.35 Sft

[illegible]

Project: **CAD MAPPING OF TEHSIL
HEAD QUARTER HOSPITALS,
PUNJAB**



Client:  GOVERNMENT OF THE PUNJAB PRIMARY & SECONDARY HEALTHCARE DEPARTMENT	Consultant:  SKAFS CONSULTANT (Pvt.) Limited <i>ENGINEERING AND ENVIRONMENT CONSULTANT</i>
--	---

Drawing Title: **THQ KHARIAN
HOSPITAL MASTER PLAN PART 1**

Drawing No. **SKAFS/KHARIAN /04**

MASTER PLAN OF THQ HOSPITAL KHARIAN

PART 2

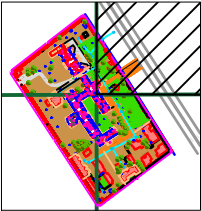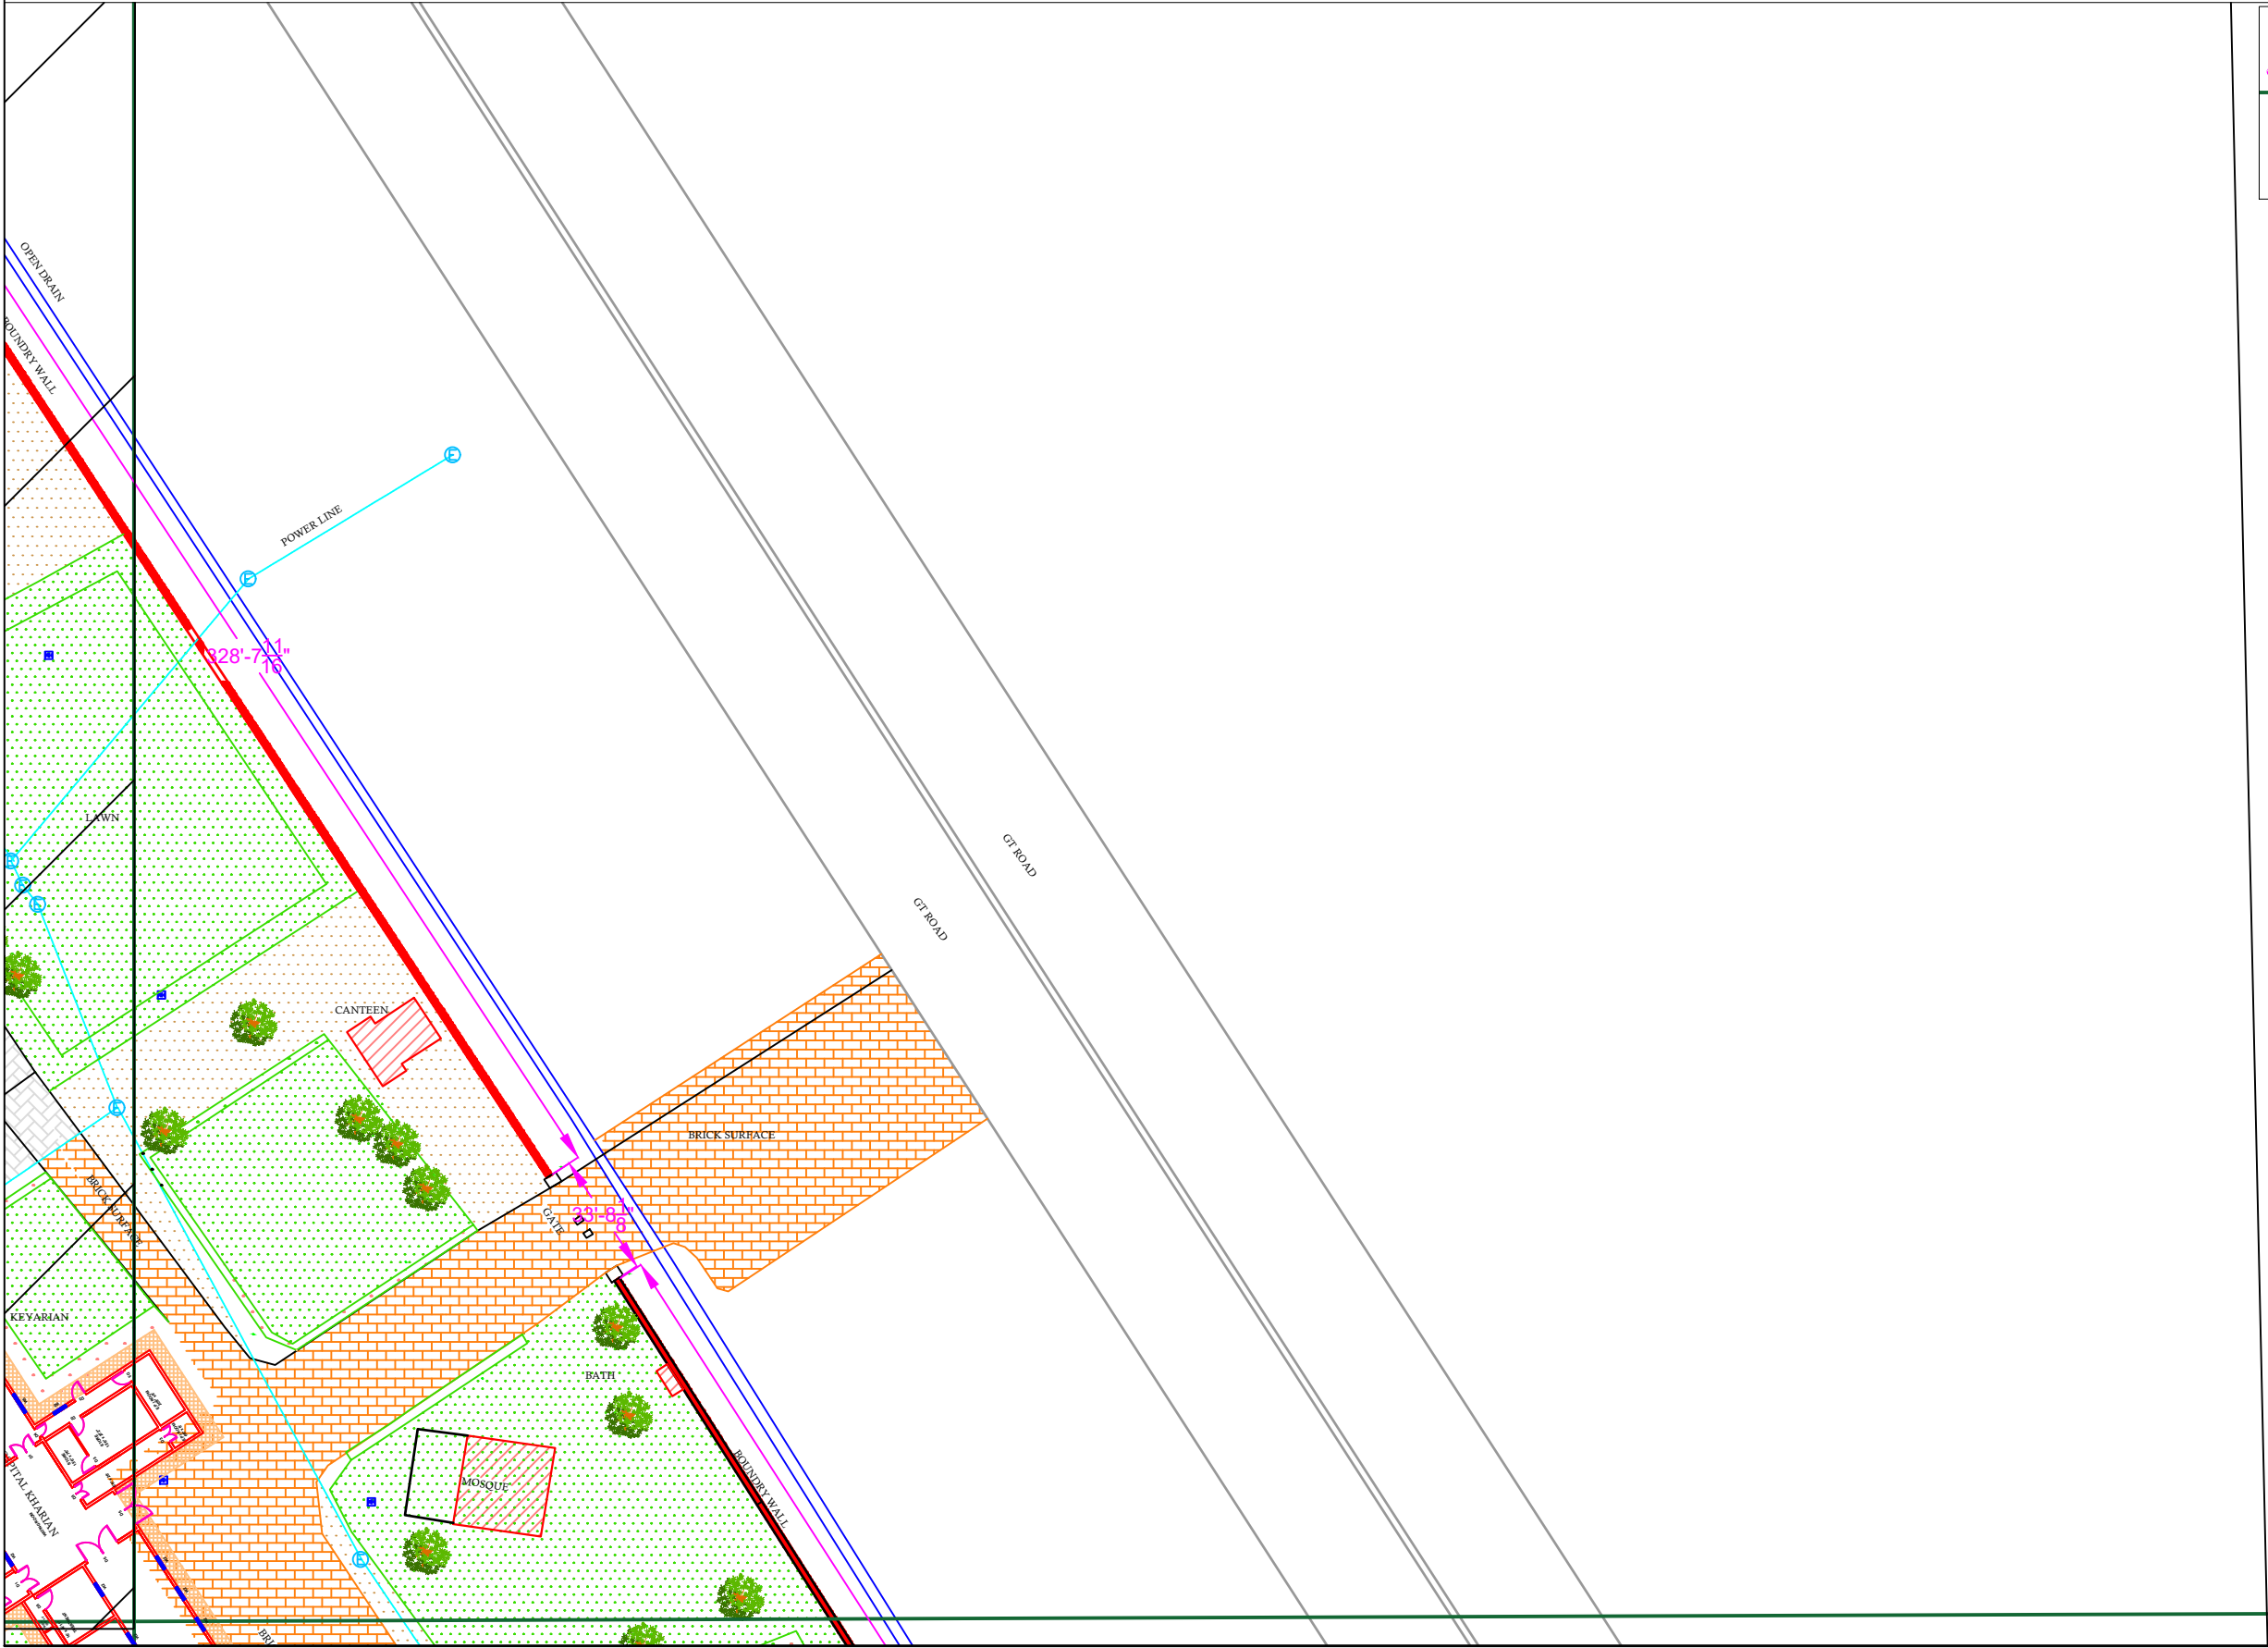

Legends:

Residential Area	
Road	
Wall	
Power Line	
OHT	
Tree	
Man Hole	
Tube Well	
Light Pole	
Lawns	
Earthen Areas	
Asphalts Roads	
Tough Pavers	
P.C.C / Plinth Protection	
Boundary Wall	
Brick Pavers / Soling	
Drain	
Tap	
Hand Pump	
Air Conditioner	
Tube Light	
Fan	
Roof Light	
Bulb	

AREA	
AREA WITHIN BOUNDARY WALL	369553.48 Sft
AREA OF CLINICAL BLOCK	46017.03 Sft
PLINTH AREA OF BLOCK	37462.35 Sft

OPENING SCHEDULE OF DOORS AND WINDOWS					
DOORS	WIDTH	HEIGHT	WINDOWS	WIDTH	HEIGHT
D1	3'-6"	7'-0"	W1	4'-0"	4'-0"
D2	4'-0"	7'-0"	W2	6'-0"	6'-0"
D4	2'-6"	7'-0"			

Project:
**CAD MAPPING OF TEHSIL
HEAD QUARTER HOSPITALS,
PUNJAB**

Client:

GOVERNMENT OF THE PUNJAB
PRIMARY & SECONDARY
HEALTHCARE DEPARTMENT

Consultant:



SKAFS CONSULTANT (Pvt.)
Limited
ENGINEERING AND ENVIRONMENT
CONSULTANT

Drawing Title:
**THQ KHARIAN
HOSPITAL MASTER PLAN PART 2**

Drawing No.
SKAFS/KHARIAN /05

MASTER PLAN OF THQ HOSPITAL KHARIAN

PART 3

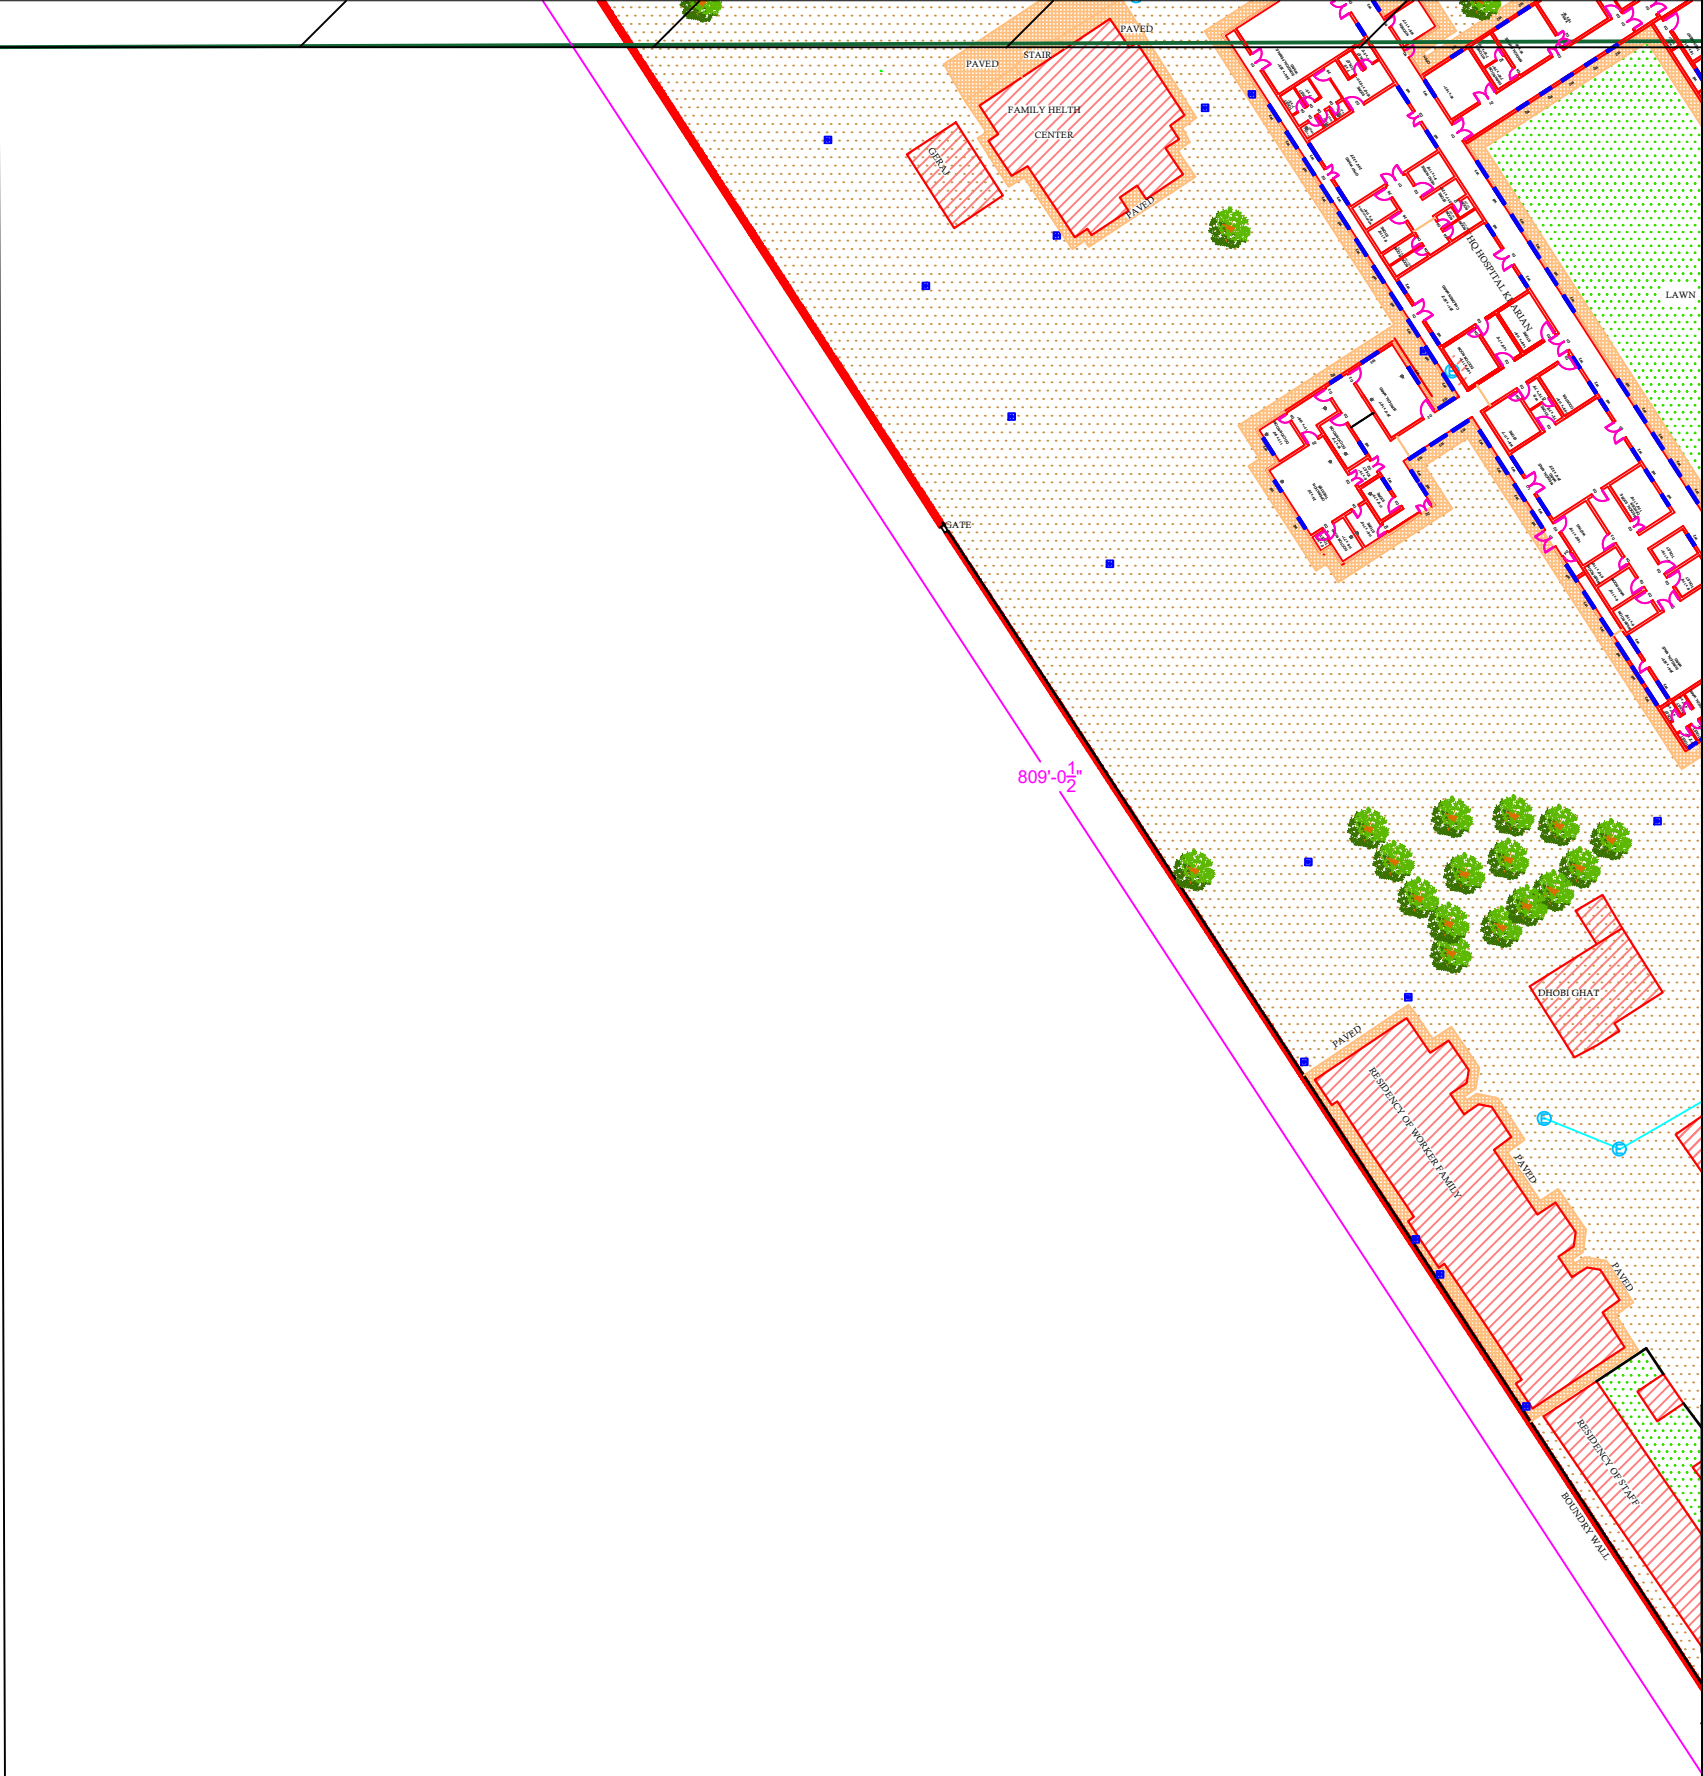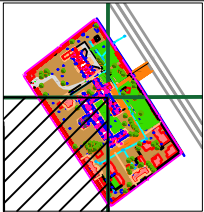

Legends:

Residential Area	
Road	
Wall	
Power Line	
OHT	
Tree	
Man Hole	
Tube Well	
Light Pole	
Lawns	
Earthen Areas	
Asphalts Roads	
Tough Pavers	
P.C.C / Plinth Protection	
Boundary Wall	
Brick Pavers / Soling	
Drain	
Tap	
Hand Pump	
Air Conditioner	
Tube Light	
Fan	
Roof Light	
Bulb	

AREA	
AREA WITHIN BOUNDARY WALL	369553.48 Sft
AREA OF CLINICAL BLOCK	46017.03 Sft
PLINTH AREA OF BLOCK	37462.35 Sft

OPENING SCHEDULE OF DOORS AND WINDOWS					
DOORS	WIDTH	HEIGHT	WINDOWS	WIDTH	HEIGHT
D1	3'-6"	7'-0"	W1	4'-0"	4'-0"
D2	4'-0"	7'-0"	W2	6'-0"	6'-0"
D4	2'-6"	7'-0"			

Project:
**CAD MAPPING OF TEHSIL
HEAD QUARTER HOSPITALS,
PUNJAB**

Client:

GOVERNMENT OF THE PUNJAB
PRIMARY & SECONDARY
HEALTHCARE DEPARTMENT



Consultant:

SKAFS CONSULTANT (Pvt.)
Limited
ENGINEERING AND ENVIRONMENT
CONSULTANT

Drawing Title:
**THQ KHARIAN
HOSPITAL MASTER PLAN PART 3**

Drawing No.
SKAFS/KHARIAN /06

MASTER PLAN OF THQ HOSPITAL KHARIAN
PART 4

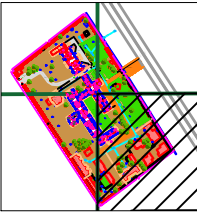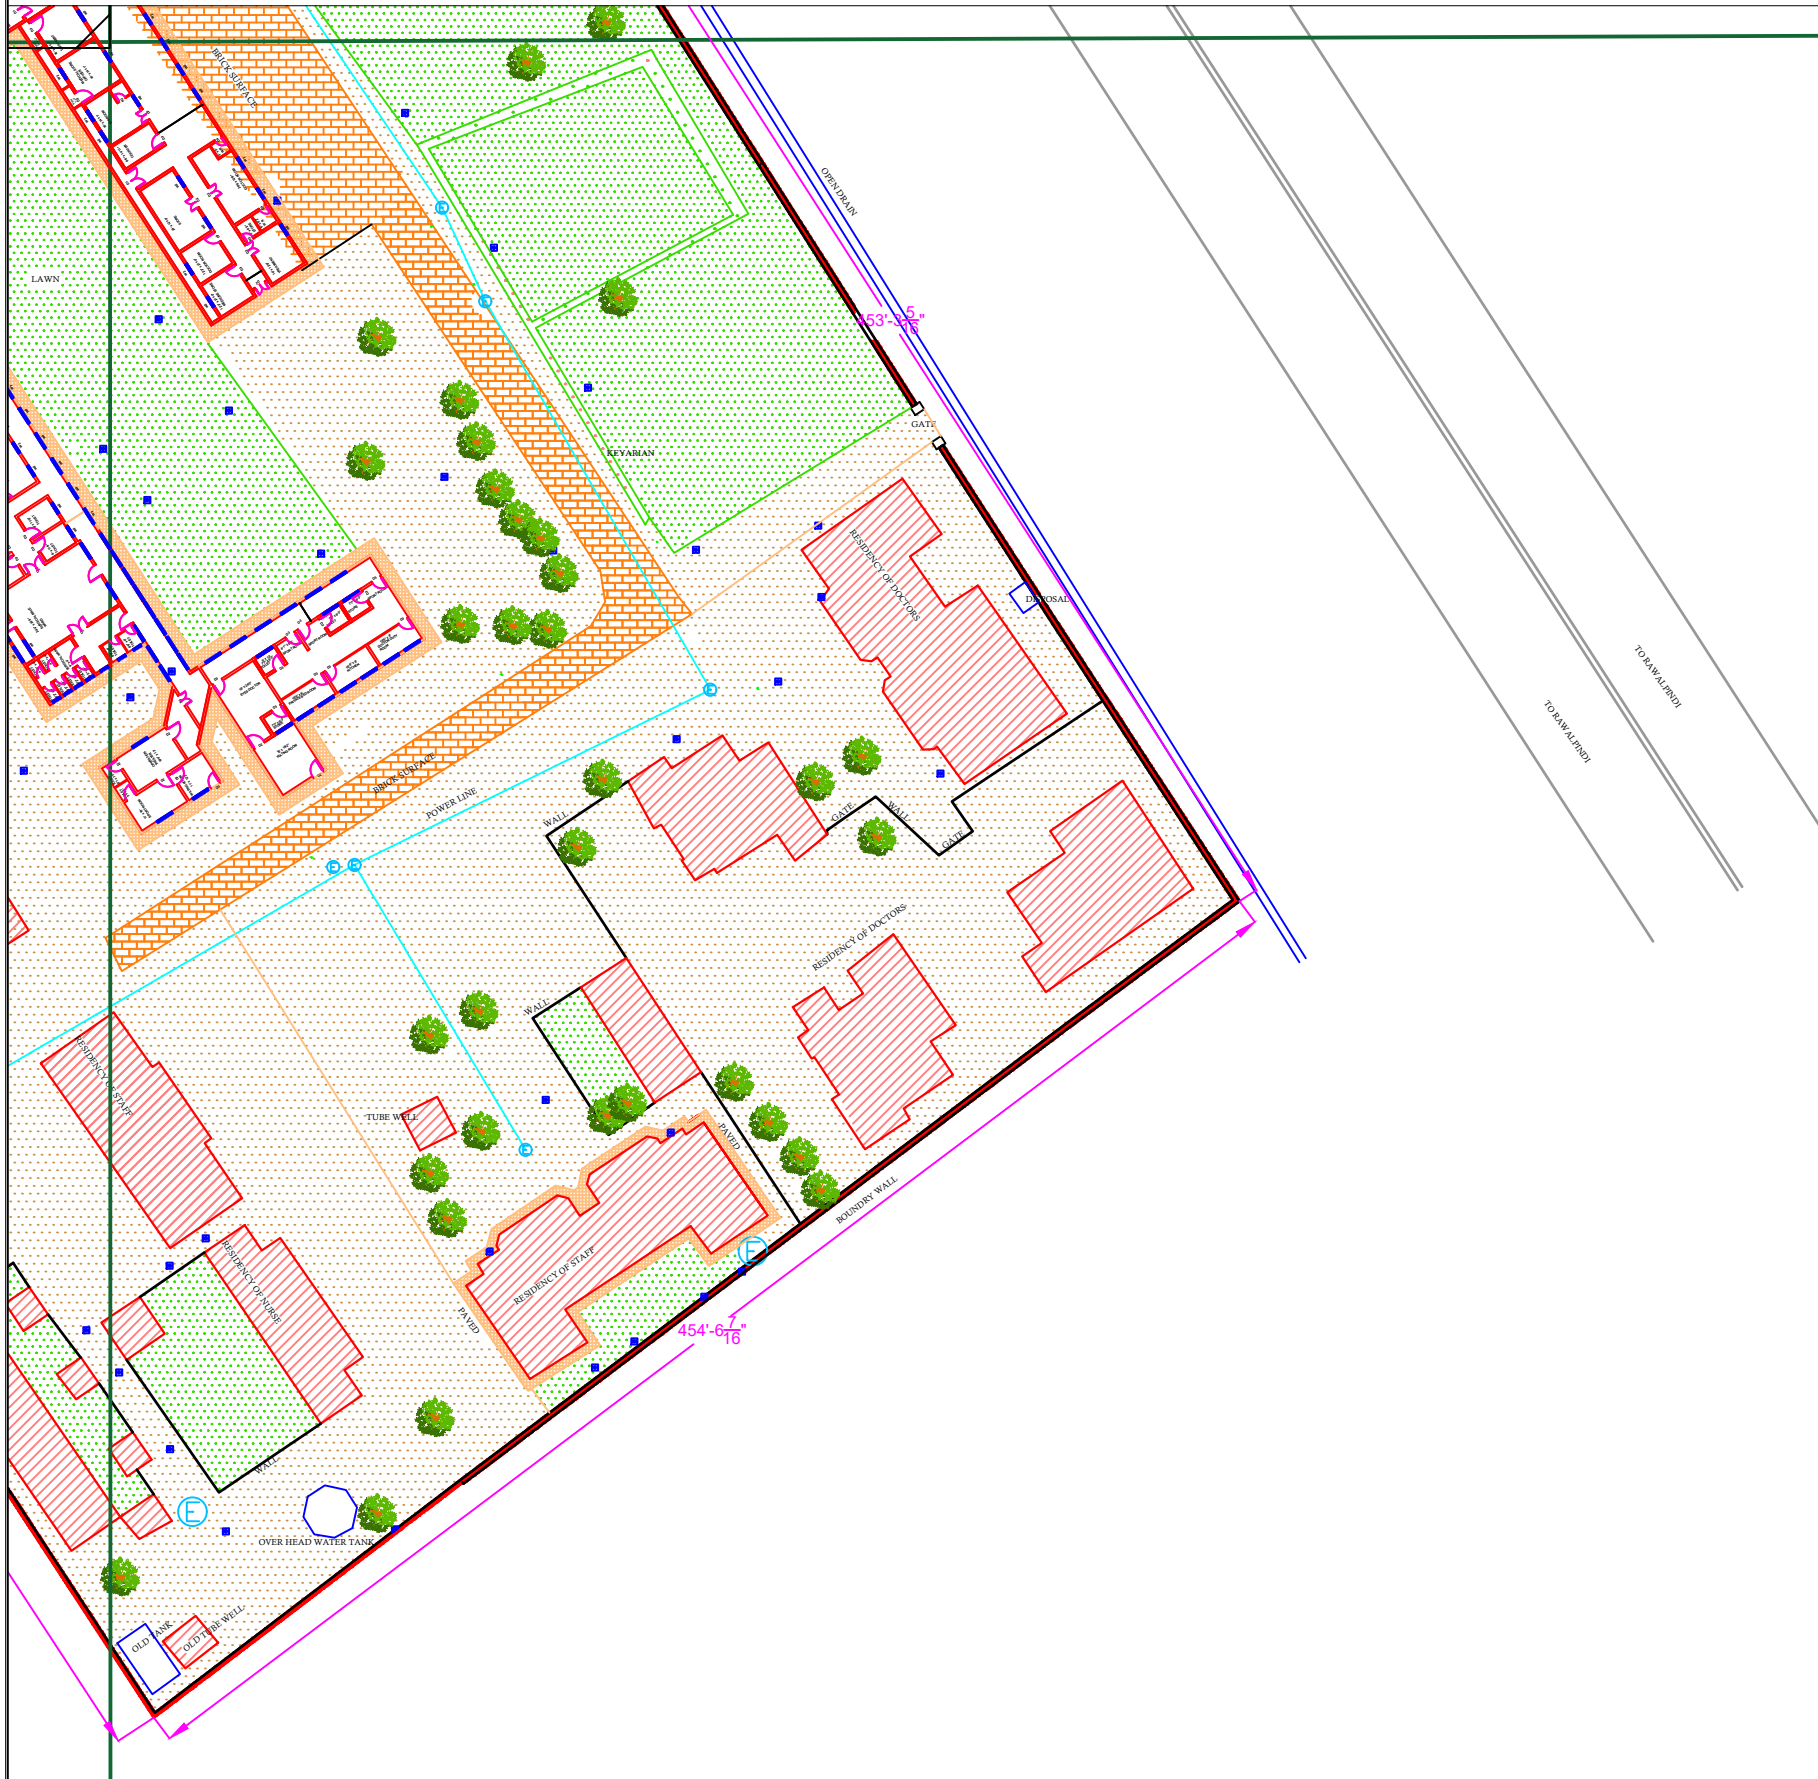

Legends:

Residential Area	
Road	
Wall	
Power Line	
OHT	
Tree	
Man Hole	
Tube Well	
Light Pole	
Lawns	
Earthen Areas	
Asphalts Roads	
Tough Pavers	
P.C.C / Plinth Protection	
Boundary Wall	
Brick Pavers / Soling	
Drain	
Tap	
Hand Pump	
Air Conditioner	
Tube Light	
Fan	
Roof Light	
Bulb	

AREA	
AREA WITHIN BOUNDARY WALL	369553.48 Sft
AREA OF CLINICAL BLOCK	46017.03 Sft
PLINTH AREA OF BLOCK	37462.35 Sft

[illegible]

Project:
**CAD MAPPING OF TEHSIL
HEAD QUARTER HOSPITALS,
PUNJAB**


Client:  GOVERNMENT OF THE PUNJAB PRIMARY & SECONDARY HEALTHCARE DEPARTMENT	Consultant:  SKAFS CONSULTANT (Pvt.) Limited <i>ENGINEERING AND ENVIRONMENT</i>
--	--

	CONFIDENTIAL
Drawing Title: THQ KHARIAN HOSPITAL MASTER PLAN PART 4	

Drawing No. **SKAFS/KHARIAN /07**

Drawing No. **SKAFS/KHARIAN /08**

CLINICAL BLOCK OF THQ HOSPITAL KHARIAN
GROUND FLOOR PART 1

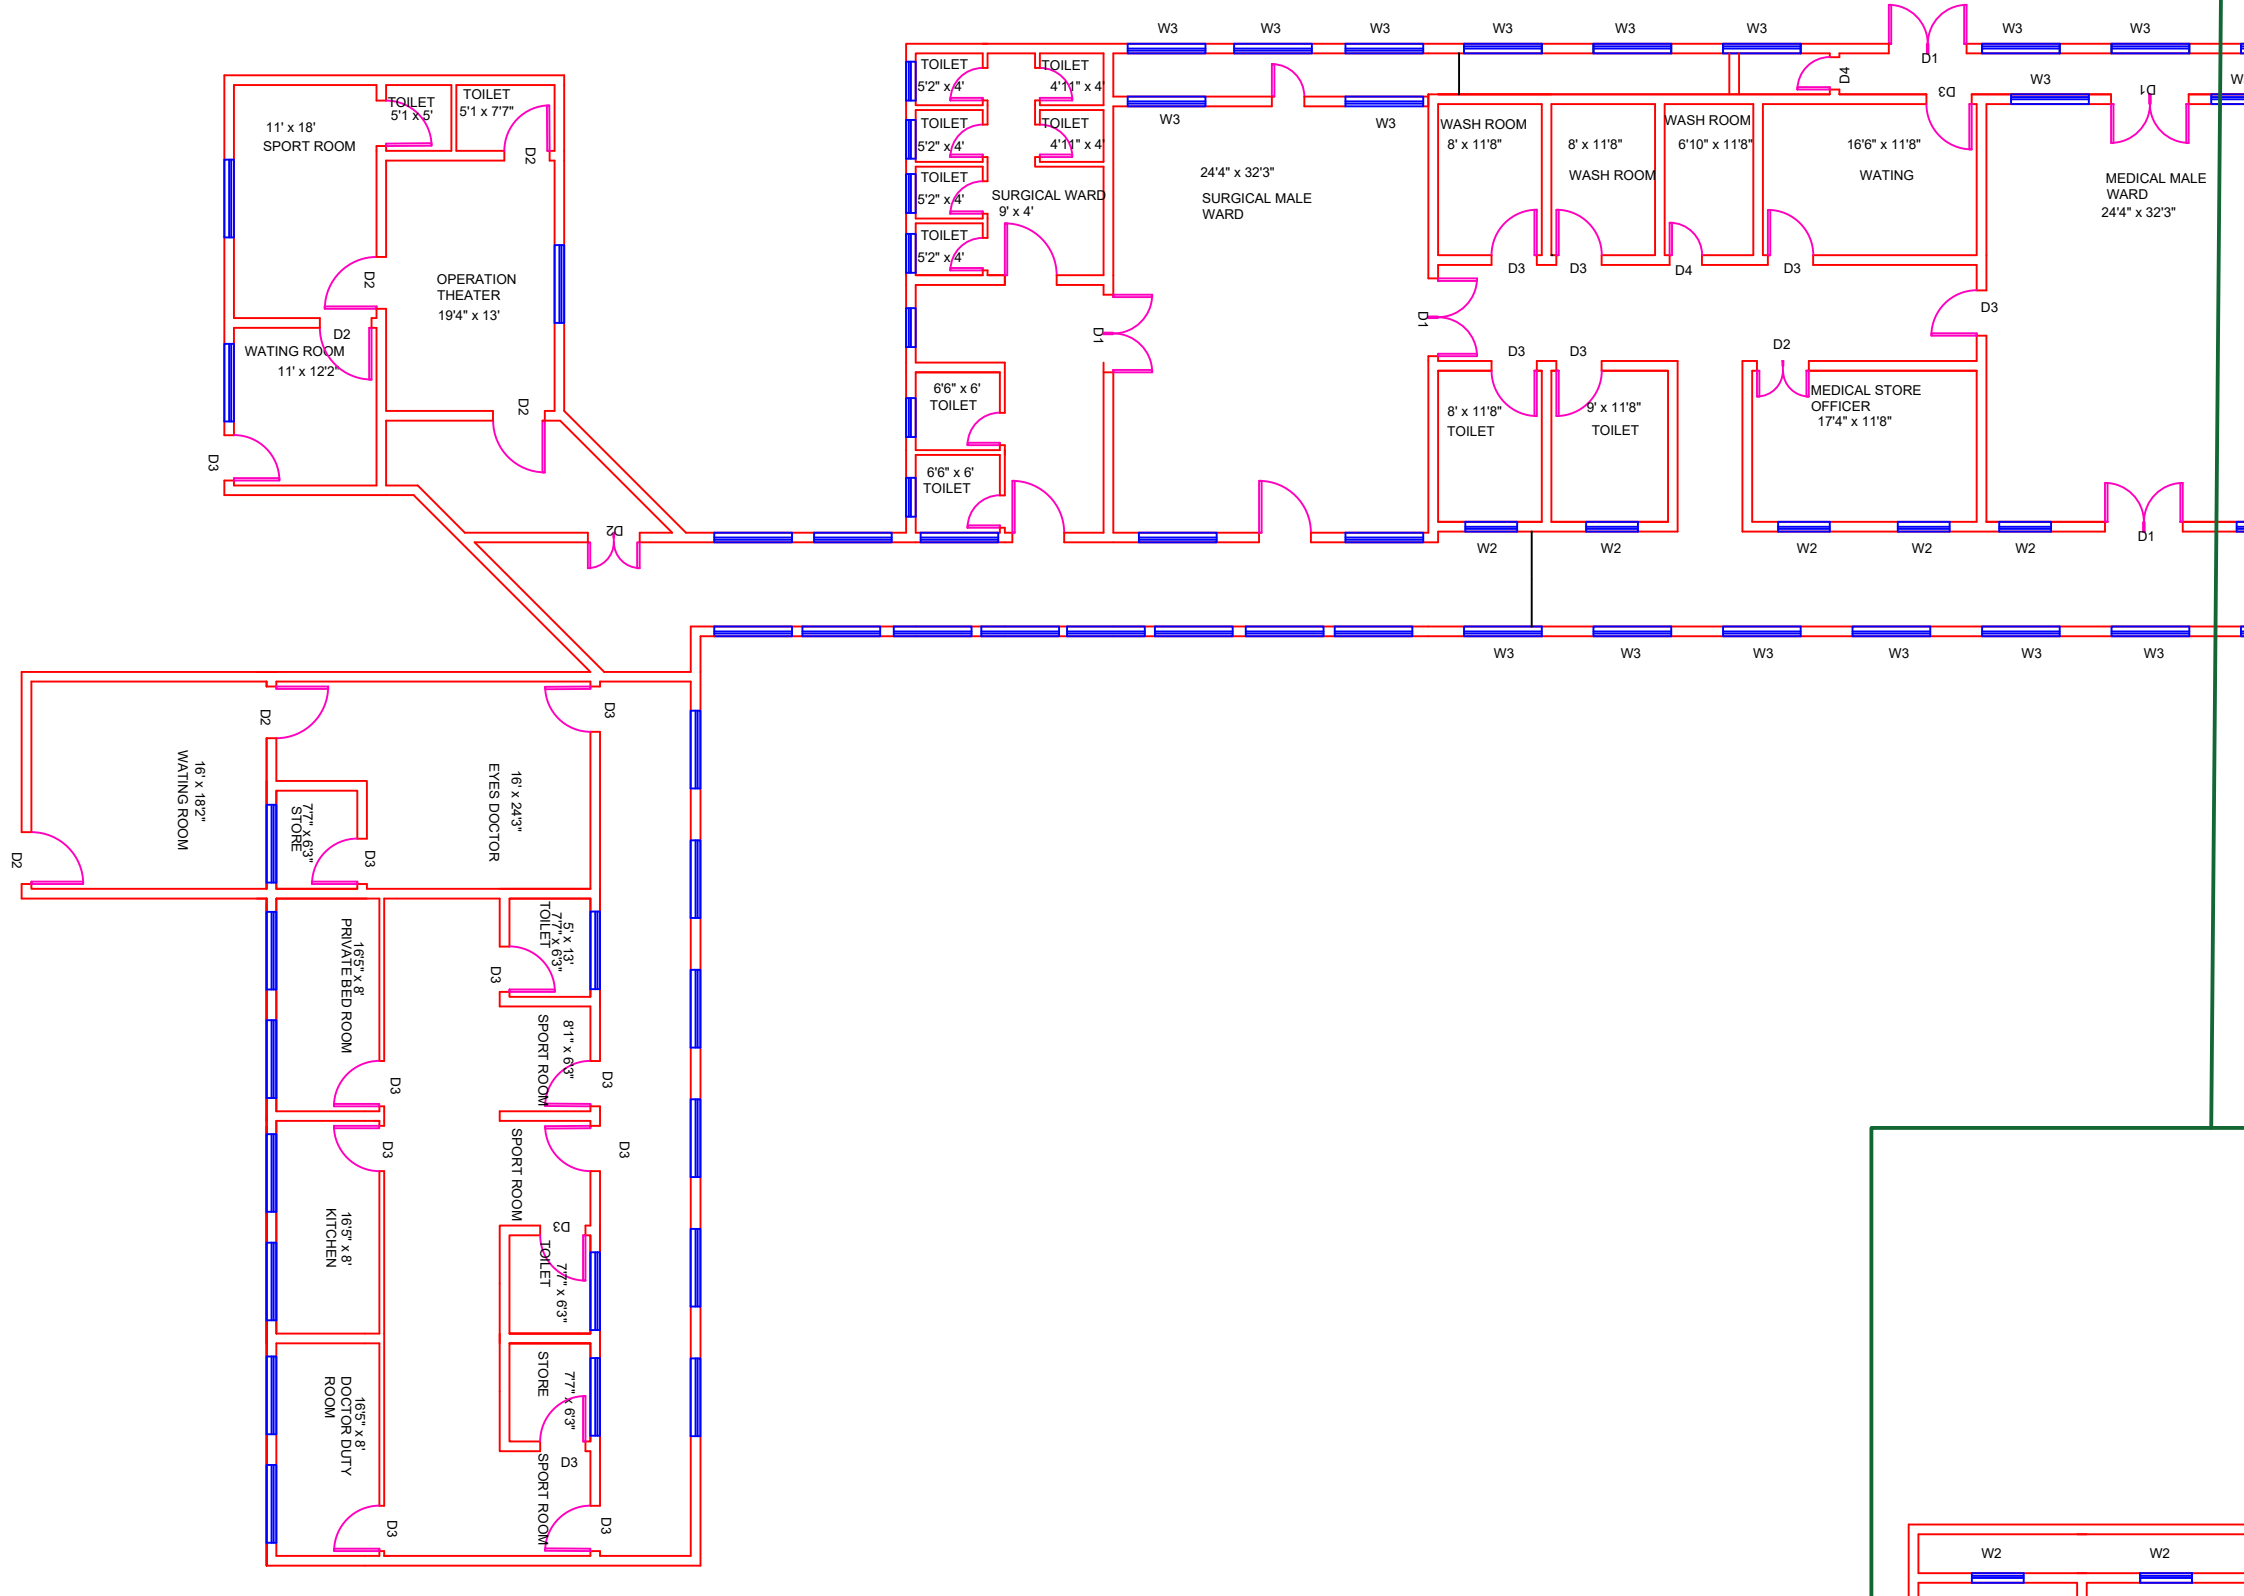

Legends:

Residential Area	
Road	
Wall	
Power Line	
OHT	
Tree	
Man Hole	
Tube Well	
Light Pole	
Lawns	
Earthen Areas	
Asphalts Roads	
Tough Pavers	
P.C.C / Plinth Protection	
Boundary Wall	
Brick Pavers / Soling	
Drain	
Tap	
Hand Pump	
Air Conditioner	
Tube Light	
Fan	
Roof Light	
Bulb	

AREA	
AREA WITHIN BOUNDARY WALL	369553.48 Sft
AREA OF CLINICAL BLOCK	46017.03 Sft
PLINTH AREA OF BLOCK	37462.35 Sft

[illegible]

Project: **CAD MAPPING OF TEHSIL
HEAD QUARTER HOSPITALS,
PUNJAB**

Client:  GOVERNMENT OF THE PUNJAB PRIMARY & SECONDARY HEALTHCARE DEPARTMENT	Consultant:  SKAFS CONSULTANT (Pvt.) Limited ENGINEERING AND ENVIRONMENT CONSULTANT
--	--

Drawing Title: **THQ KHARIAN
CLINICAL BLOCK PLAN (PART 1)**

Drawing No. **SKAFS/KHARIAN /09**

The floor plan illustrates a comprehensive hospital ward complex with the following details:

- Top Section:** Includes a central **OPERATION THEATER** (24' x 20') flanked by **DOCTOR ROOM**s (11'6" x 7'7" and 11'7" x 9'4"). Support spaces include **STORE**s (11'6" x 7'10" and 11'9" x 7'3") and **TOILET**s (5' x 3'6" and 6' x 7'3").
- Middle Section:** Features a **SURGICAL WARD** (24'4" x 16'1") and a **CHILDREN WARD** (25'1" x 32'3"). It also contains several **DOCTOR ROOM**s (14'9" x 11'7" and 14'9" x 11'9") and **STORE**s.
- Central Core:** A cluster of rooms including a **NURSING COUNTER** (8' x 11'8"), **ROOM**s (21'0" x 11'8" and 24' x 11'8"), a **HEAD NURSE** (9'1" x 11'8"), and a **STORE** (5'11" x 12'5").
- Right Section:** Contains a **GYNW WARD** (24'4" x 32'3") and a **SURGICAL FEMALE WARD** (24'4" x 32'3"). It includes multiple **TOILET**s (4' x 6'2", 4' x 4', 4' x 6', 7' x 5', and 7' x 5'5") and **STORE**s.
- Bottom Section:** Includes a **KITCHEN** (10'5" x 11'7"), a **DARK ROOM** (7'10" x 7'6"), another **KITCHEN** (7'10" x 7'6"), and a **MADICAL OFFICE** (16' x 16').
- Infrastructure:** The plan is defined by a network of corridors and walls. Windows are labeled W1, W2, and W3. Doors are labeled D1 through D4. The layout uses a color-coding system: yellow for patient wards, light blue for administrative/clinical offices, and light green for support areas.

Residential Area	
Road	
Wall	
Power Line	
OHT	
Tree	
Man Hole	
Tube Well	
Light Pole	
Lawns	
Earthen Areas	
Asphalts Roads	
Tough Pavers	
P.C.C / Plinth Protection	
Boundary Wall	
Brick Pavers / Soling	
Drain	
Tap	
Hand Pump	
Air Conditioner	
Tube Light	
Fan	
Roof Light	
Bulb	

AREA	
AREA WITHIN BOUNDARY WALL	369553.48 Sft
AREA OF CLINICAL BLOCK	46017.03 Sft
PLINTH AREA OF BLOCK	37462.35 Sft

[illegible]


Project: **CAD MAPPING OF TEHSIL
HEAD QUARTER HOSPITALS,
PUNJAB**

Client:  GOVERNMENT OF THE PUNJAB PRIMARY & SECONDARY HEALTHCARE DEPARTMENT	Consultant:  SKAFS CONSULTANT (Pvt.) Limited <i>ENGINEERING AND ENVIRONMENT CONSULTANT</i>
--	---


Drawing Title: **THQ KHARIAN
CLINICAL BLOCK PLAN (PART 2)**

Drawing No. **SKAFS/KHARIAN /10**

CLINICAL BLOCK OF THQ HOSPITAL KHARIAN
GROUND FLOOR PART 3

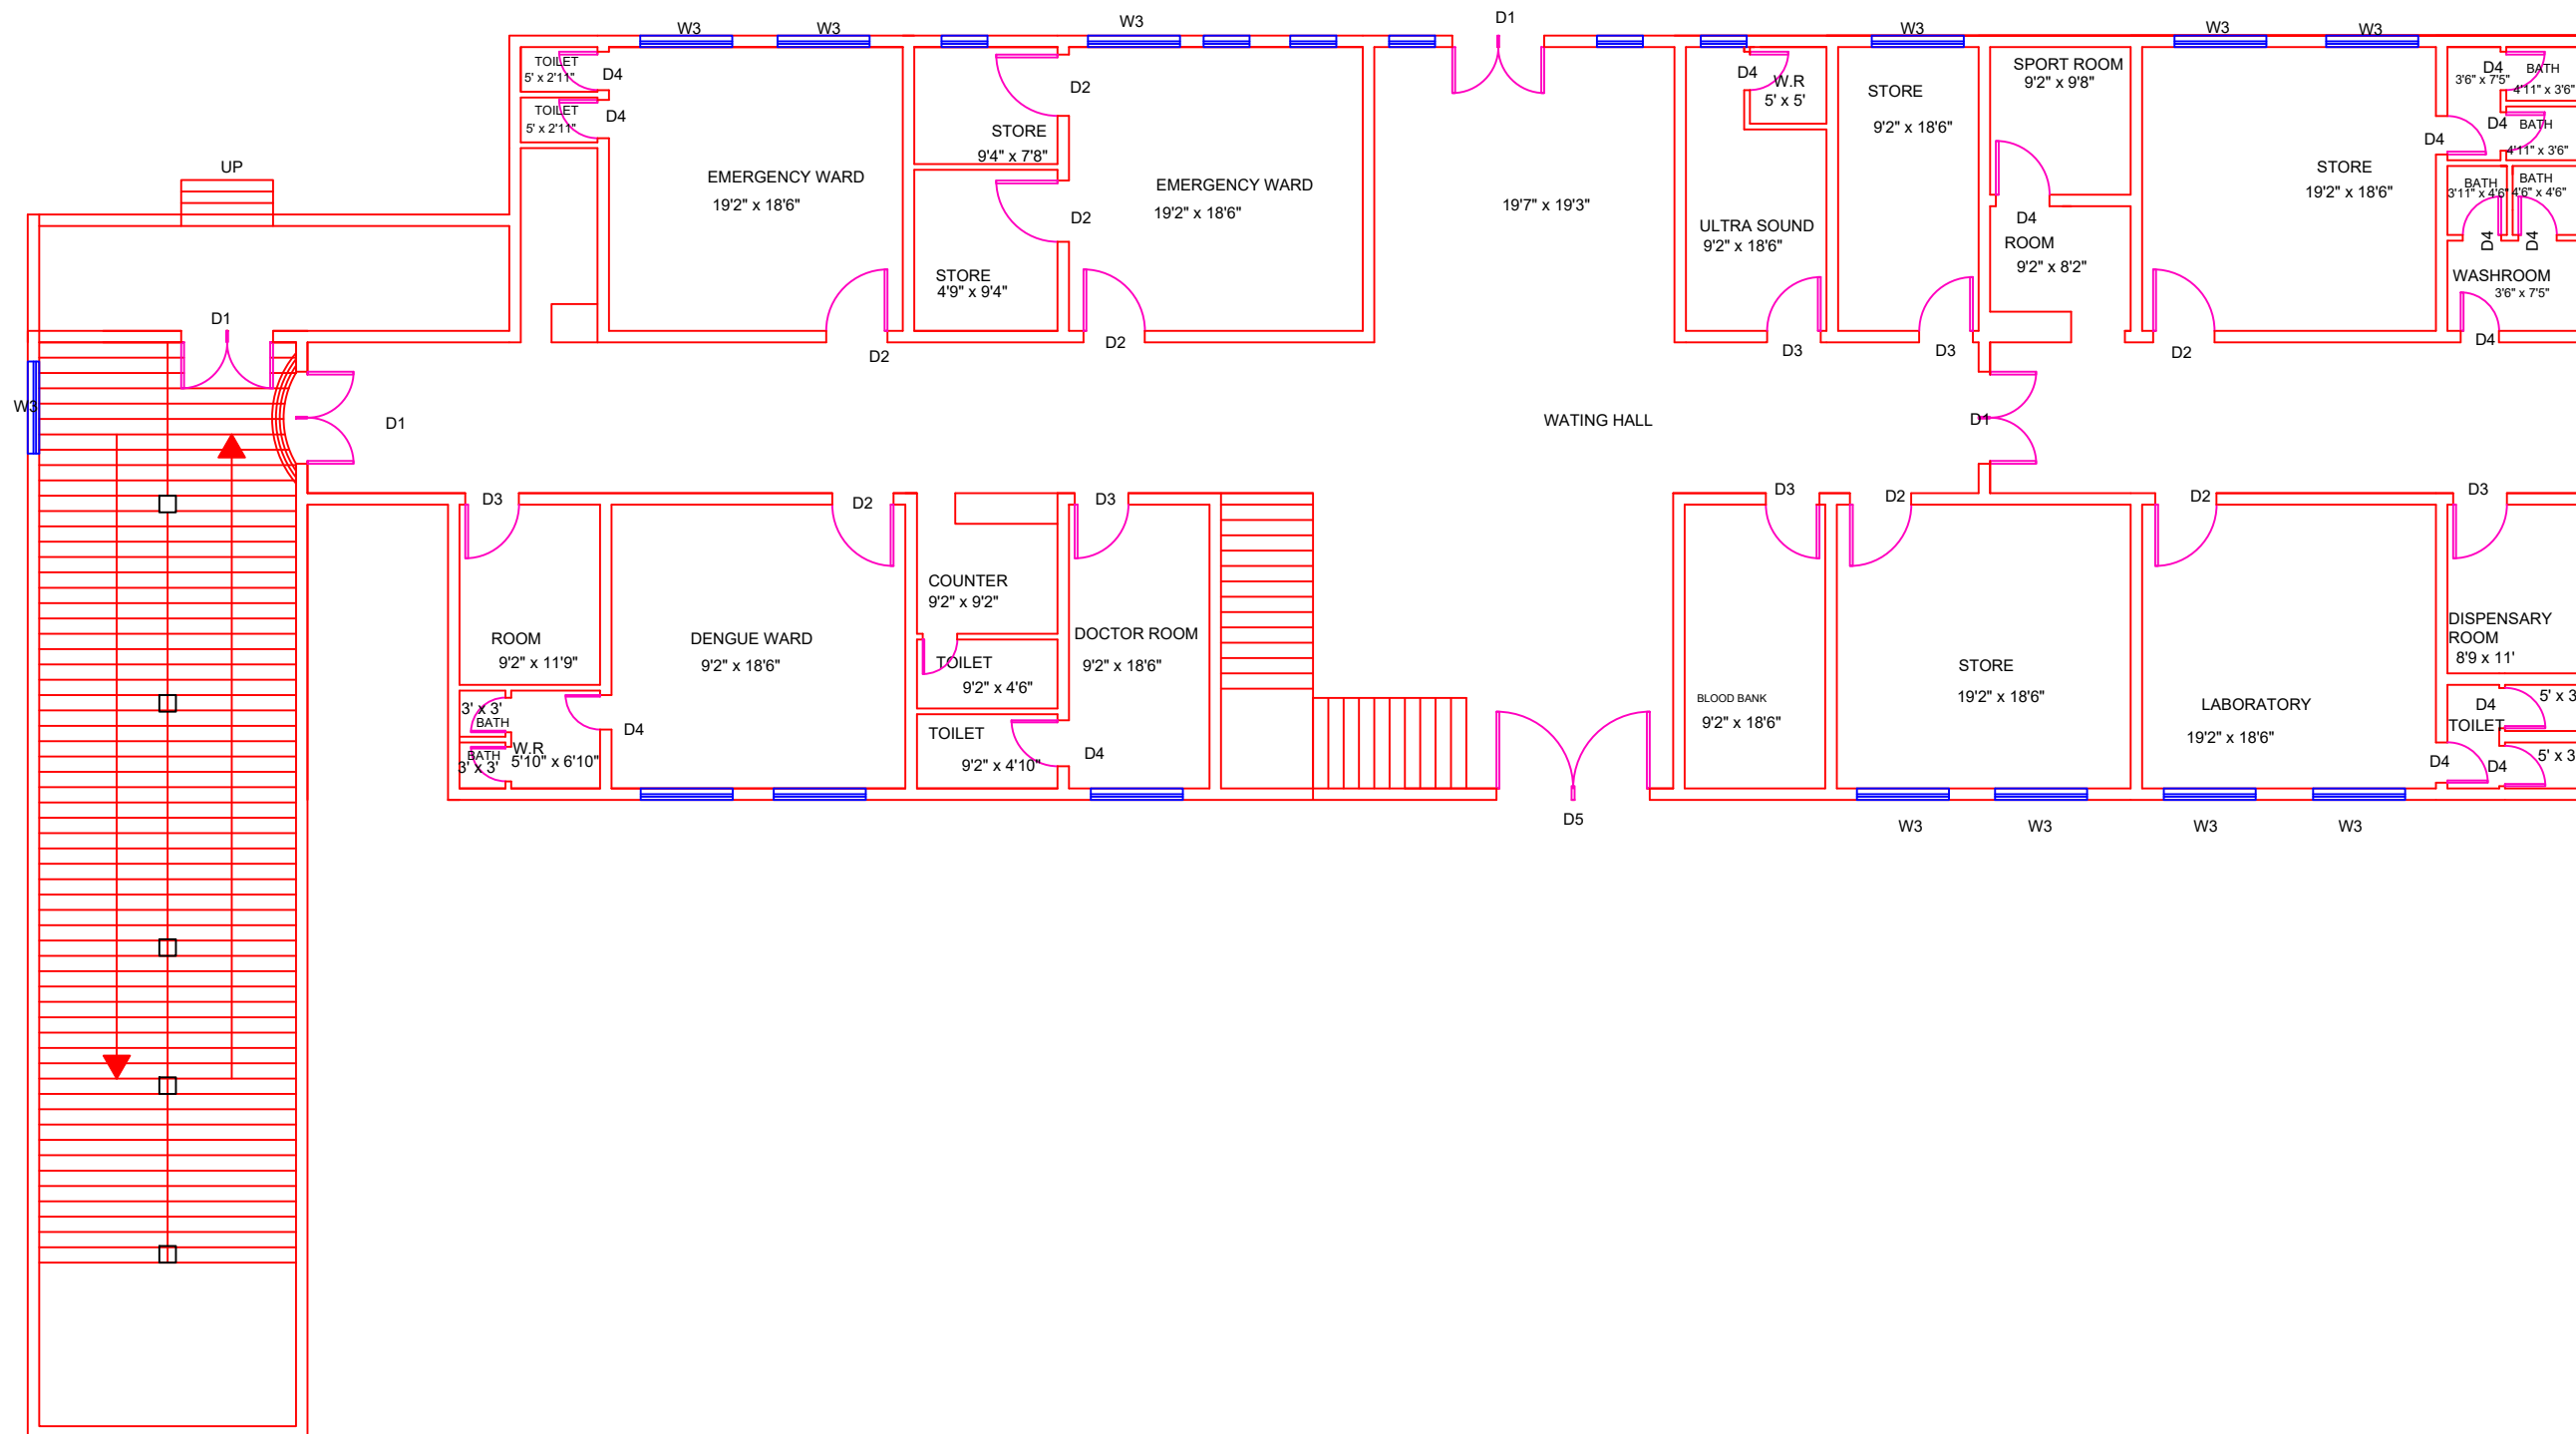

Legends:

 Residential Area	
Road	
Wall	
Power Line	
OHT	
Tree	
Man Hole	
Tube Well	
Light Pole	
Lawns	
Earthen Areas	
Asphalts Roads	
Tough Pavers	
P.C.C / Plinth Protection	
Boundary Wall	
Brick Pavers / Soling	
Drain	
Tap	
Hand Pump	
Air Conditioner	
Tube Light	
Fan	
Roof Light	
Bulb	

AREA	
AREA WITHIN BOUNDARY WALL	369553.48 Sft
AREA OF CLINICAL BLOCK	46017.03 Sft
PLINTH AREA OF BLOCK	37462.35 Sft

[illegible]

Project: **CAD MAPPING OF TEHSIL
HEAD QUARTER HOSPITALS,
PUNJAB**


Client:  GOVERNMENT OF THE PUNJAB PRIMARY & SECONDARY HEALTHCARE DEPARTMENT	Consultant:  SKAFS CONSULTANT (Pvt.) Limited <i>ENGINEERING AND ENVIRONMENT</i>
--	--

Drawing Title: **THQ KHARIAN
CLINICAL BLOCK PLAN (PART 3)**

Drawing No. **SKAFS/KHARIAN /11**

CLINICAL BLOCK OF THQ HOSPITAL KHARIAN

GROUND FLOOR PART 4

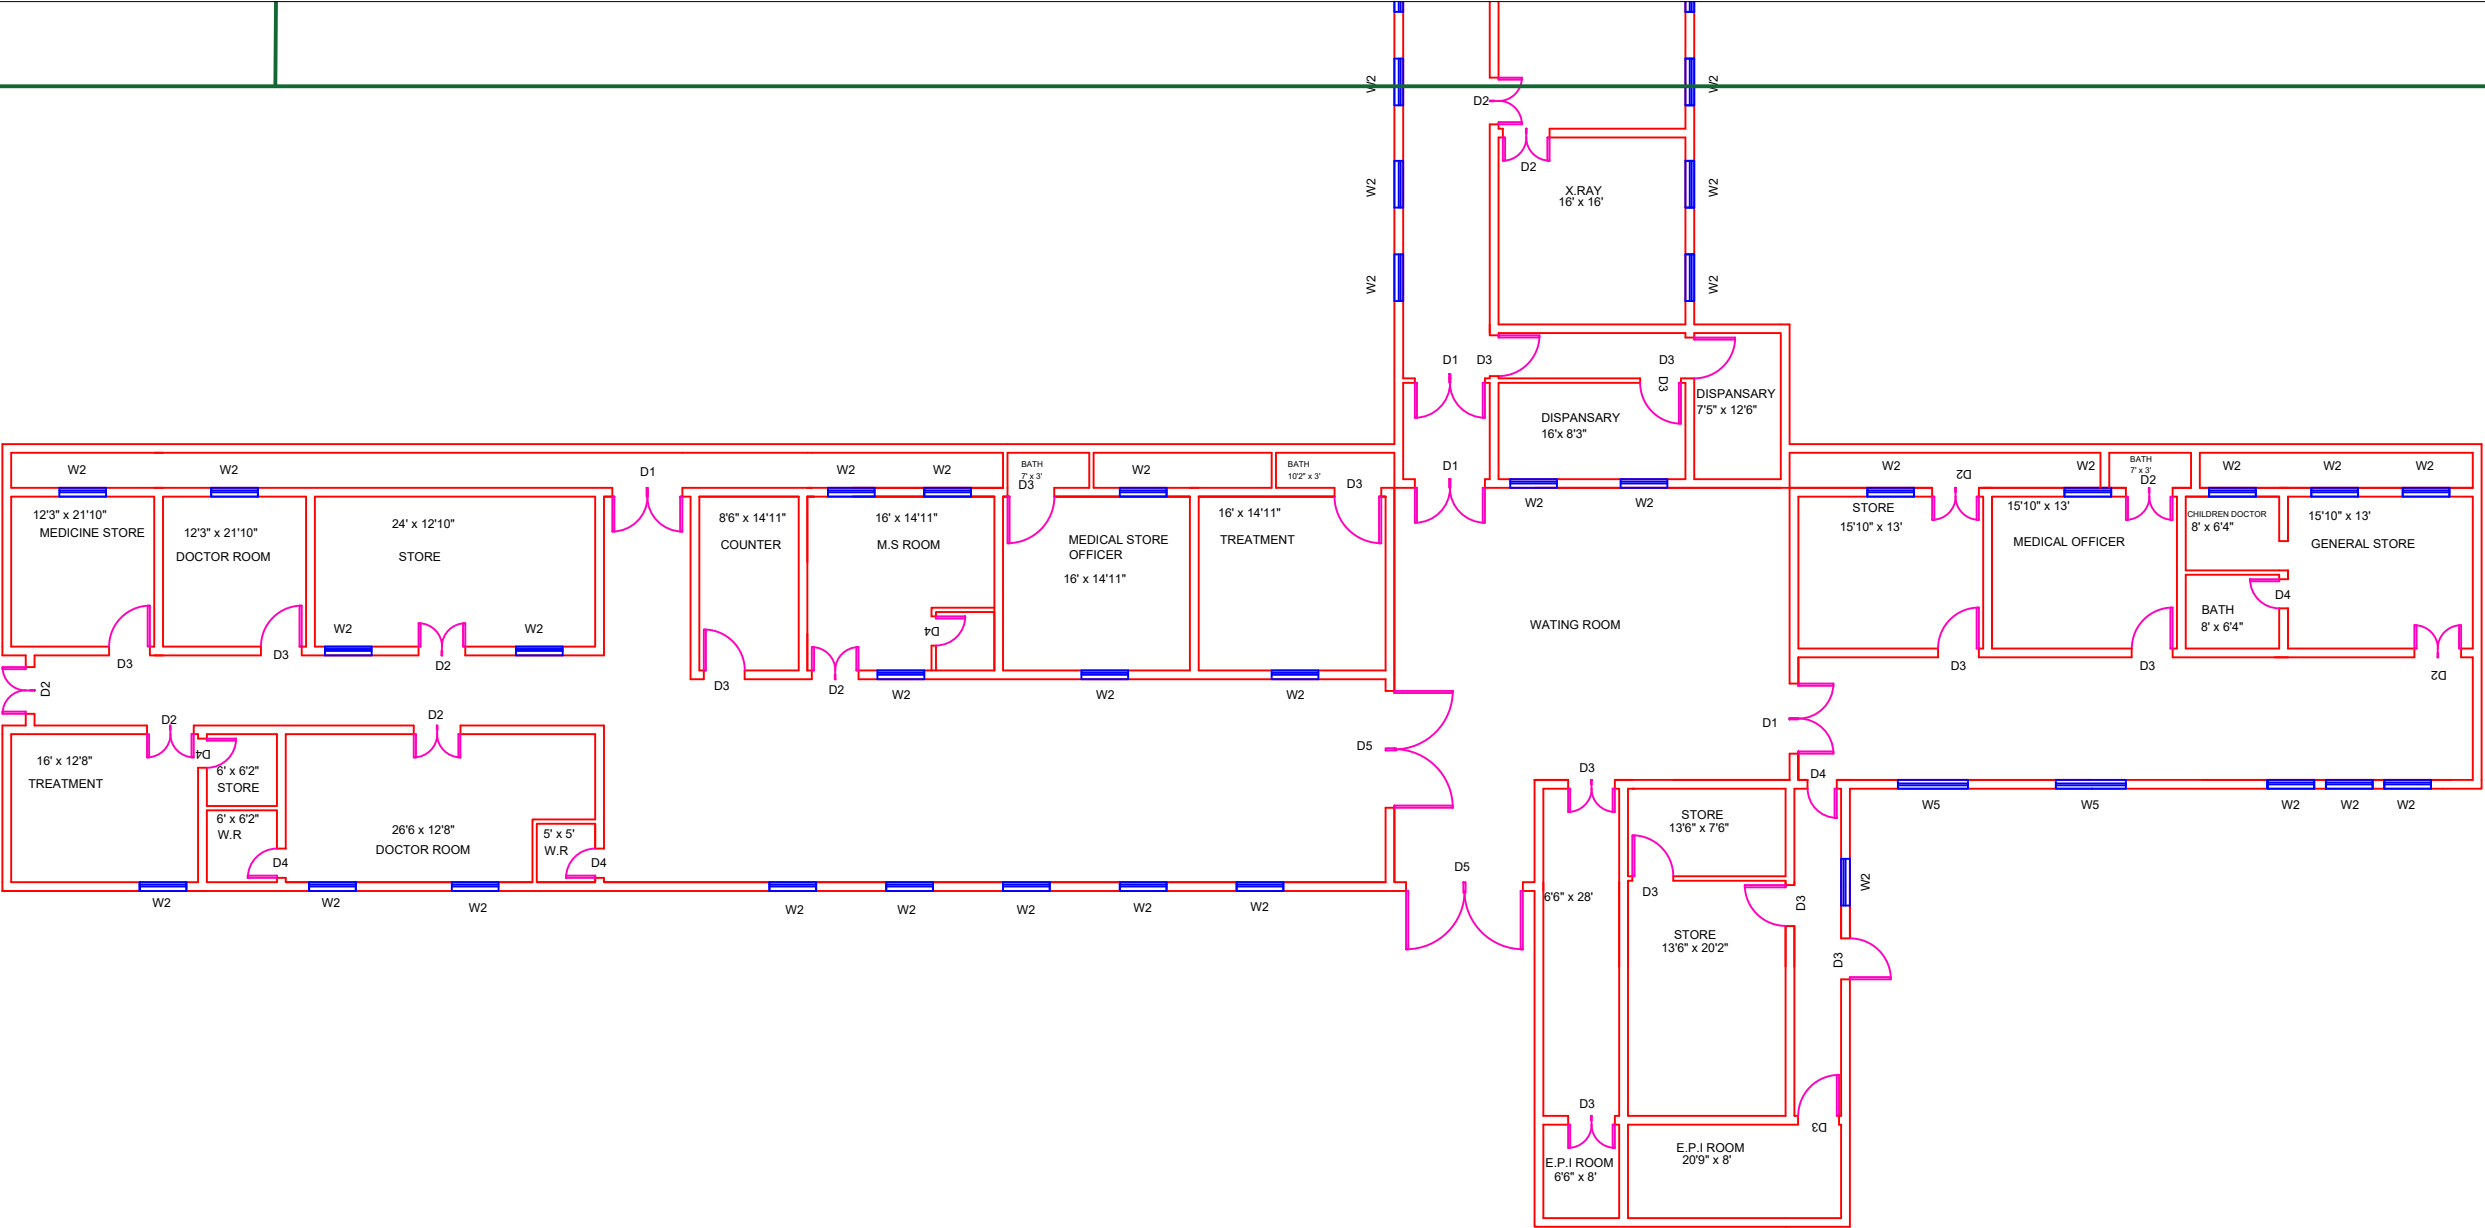

Legends:	
Residential Area	
Road	
Wall	
Power Line	
OHT	
Tree	
Man Hole	
Tube Well	
Light Pole	
Lawns	
Earthen Areas	
Asphalts Roads	
Tough Pavers	
P.C.C / Plinth Protection	
Boundary Wall	
Brick Pavers / Soling	
Drain	
Tap	
Hand Pump	
Air Conditioner	
Tube Light	
Fan	
Roof Light	
Bulb	

AREA	
AREA WITHIN BOUNDARY WALL	369553.48 Sft
AREA OF CLINICAL BLOCK	46017.03 Sft
PLINTH AREA OF BLOCK	37462.35 Sft

OPENING SCHEDULE OF DOORS AND WINDOWS					
DOORS	WIDTH	HEIGHT	WINDOWS	WIDTH	HEIGHT
D1	3'-6"	7'-0"	W1	4'-0"	4'-0"
D2	4'-0"	7'-0"	W2	6'-0"	6'-0"
D4	2'-6"	7'-0"			


Project:
**CAD MAPPING OF TEHSIL
HEAD QUARTER HOSPITALS,
PUNJAB**

Client: GOVERNMENT OF THE PUNJAB PRIMARY & SECONDARY HEALTHCARE DEPARTMENT	Consultant: SKAFS CONSULTANT (Pvt.) Limited ENGINEERING AND ENVIRONMENT CONSULTANT
---	--

Drawing Title:
**THQ KHARIAN
CLINICAL BLOCK PLAN (PART 4)**

Drawing No.
SKAFS/KHARIAN /12

CLINICAL BLOCK OF THQ HOSPITAL KHARIAN
FIRST FLOOR PART 1

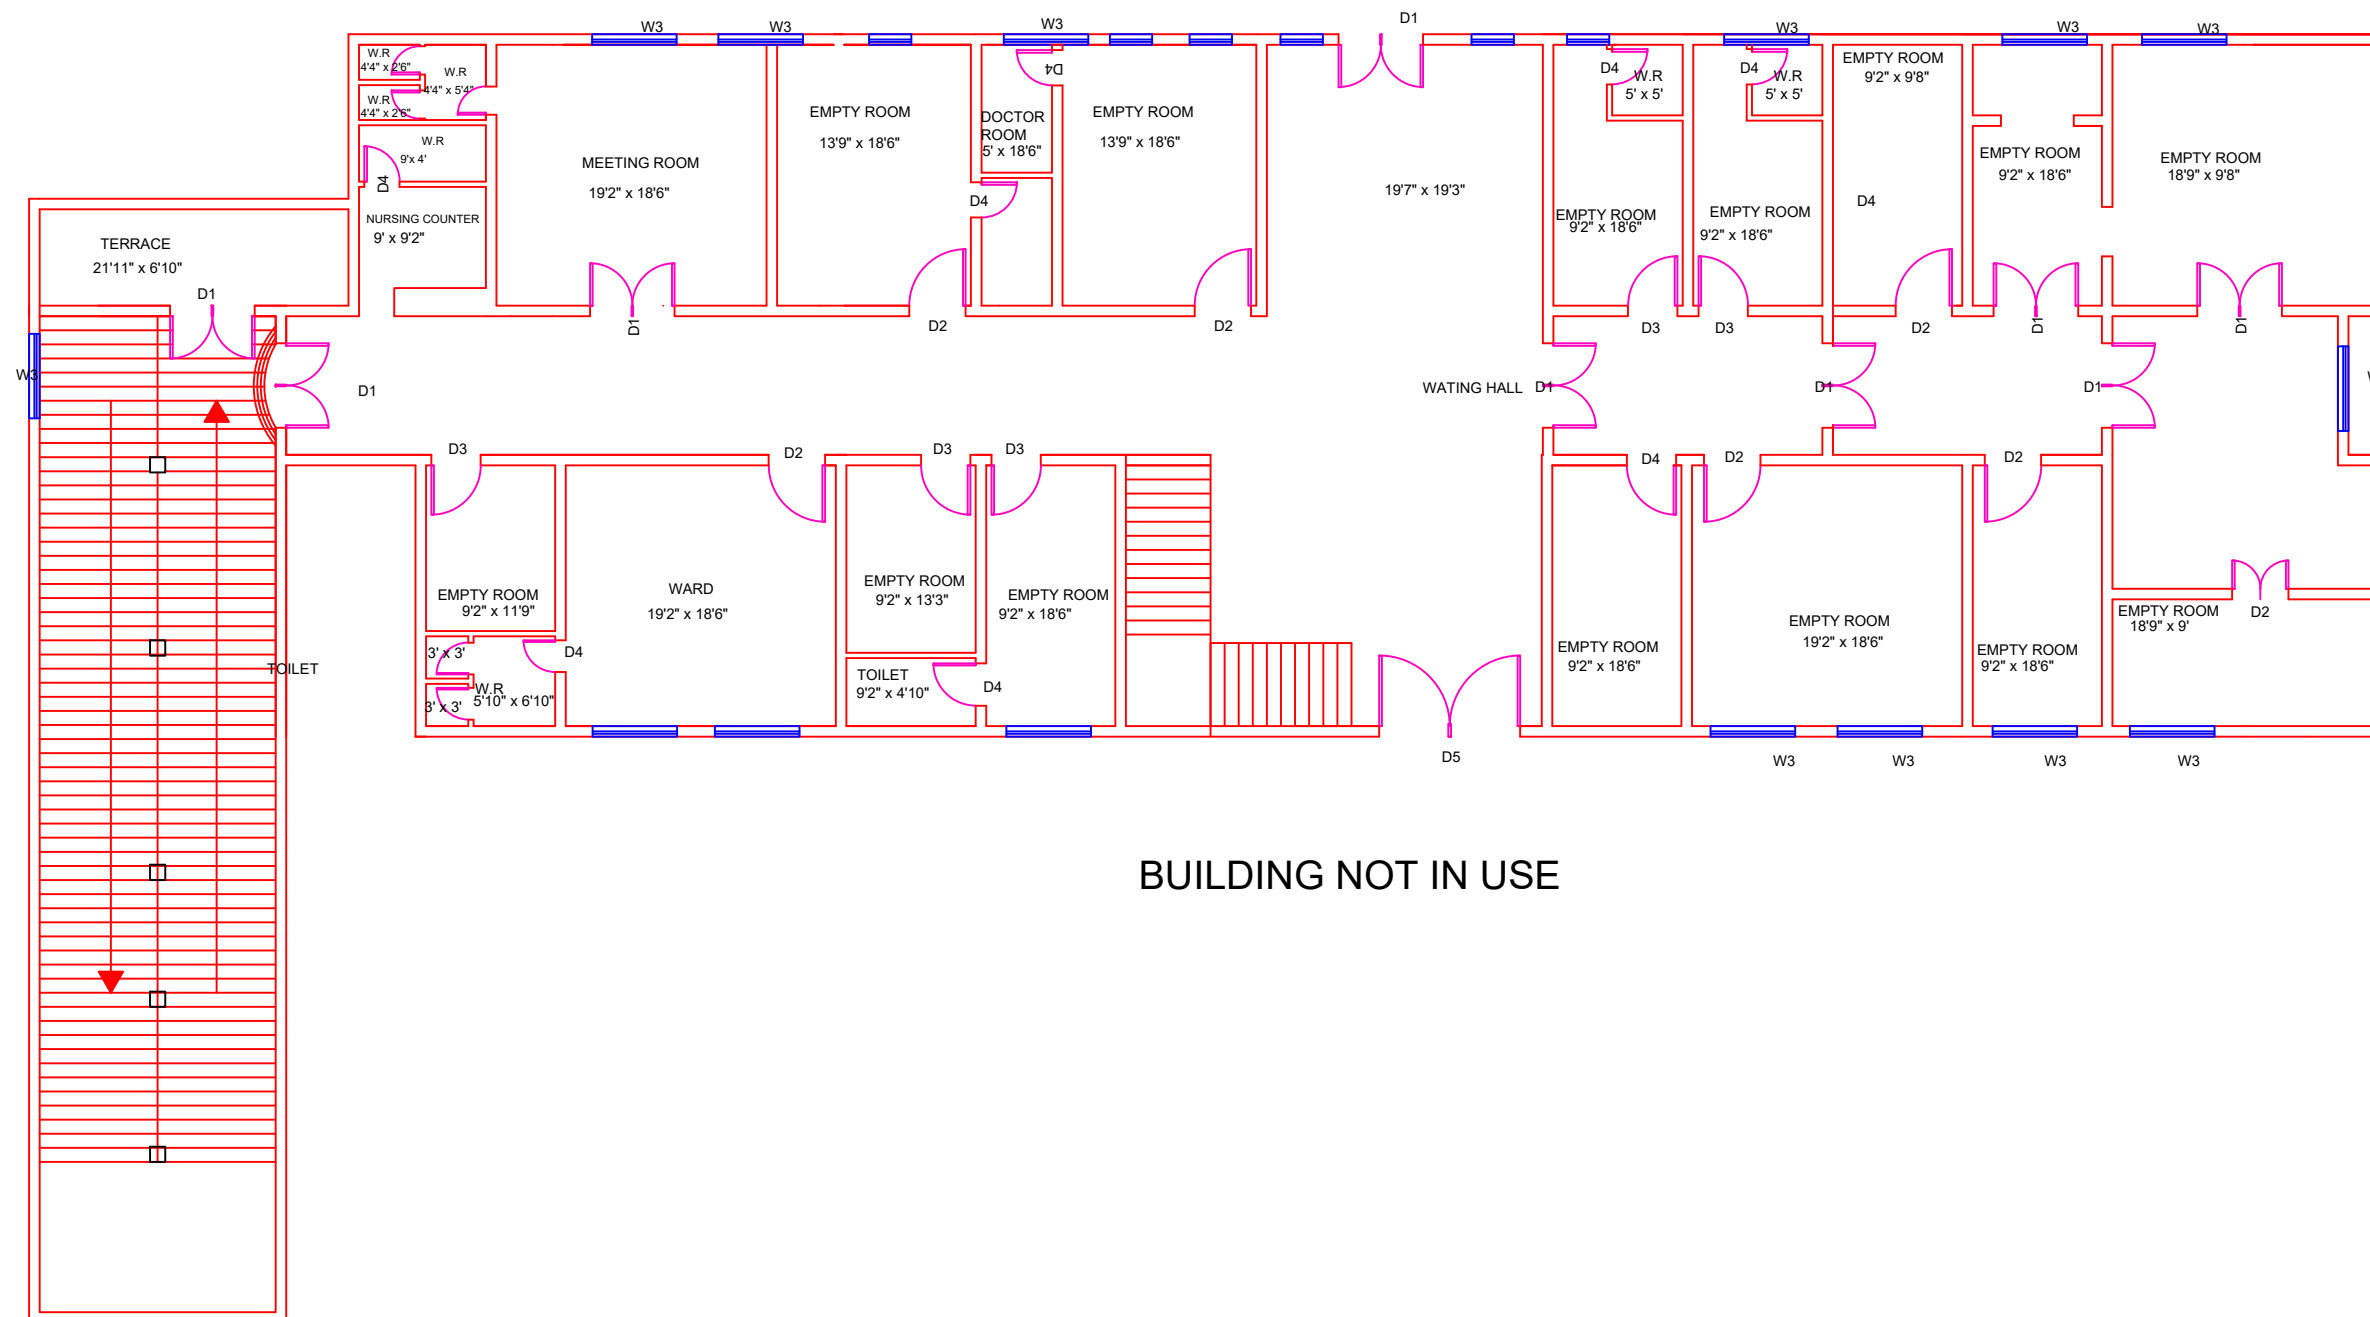

BUILDING NOT IN USE

Legends:

Residential Area	
Road	
Wall	
Power Line	
OHT	
Tree	
Man Hole	
Tube Well	
Light Pole	
Lawns	
Earthen Areas	
Asphalts Roads	
Tough Pavers	
P.C.C / Plinth Protection	
Boundary Wall	
Brick Pavers / Soling	
Drain	
Tap	
Hand Pump	
Air Conditioner	
Tube Light	
Fan	
Roof Light	
Bulb	

AREA	
AREA WITHIN BOUNDARY WALL	369553.48 Sft
AREA OF CLINICAL BLOCK	46017.03 Sft
PLINTH AREA OF BLOCK	37462.35 Sft

[illegible]

Project: **CAD MAPPING OF TEHSIL
HEAD QUARTER HOSPITALS,
PUNJAB**


Client:  GOVERNMENT OF THE PUNJAB PRIMARY & SECONDARY HEALTHCARE DEPARTMENT	Consultant:  SKAFS CONSULTANT (Pvt.) Limited <i>ENGINEERING AND ENVIRONMENT</i>
--	--

Drawing Title:		THQ KHARIAN FIRST FLOOR PLAN (PART 1)
----------------	--	--

Drawing No. **SKAFS/KHARIAN /13**

ELECTRICAL LAYOUT PLAN OF THQ HOSPITAL KHARIAN

GROUND FLOOR

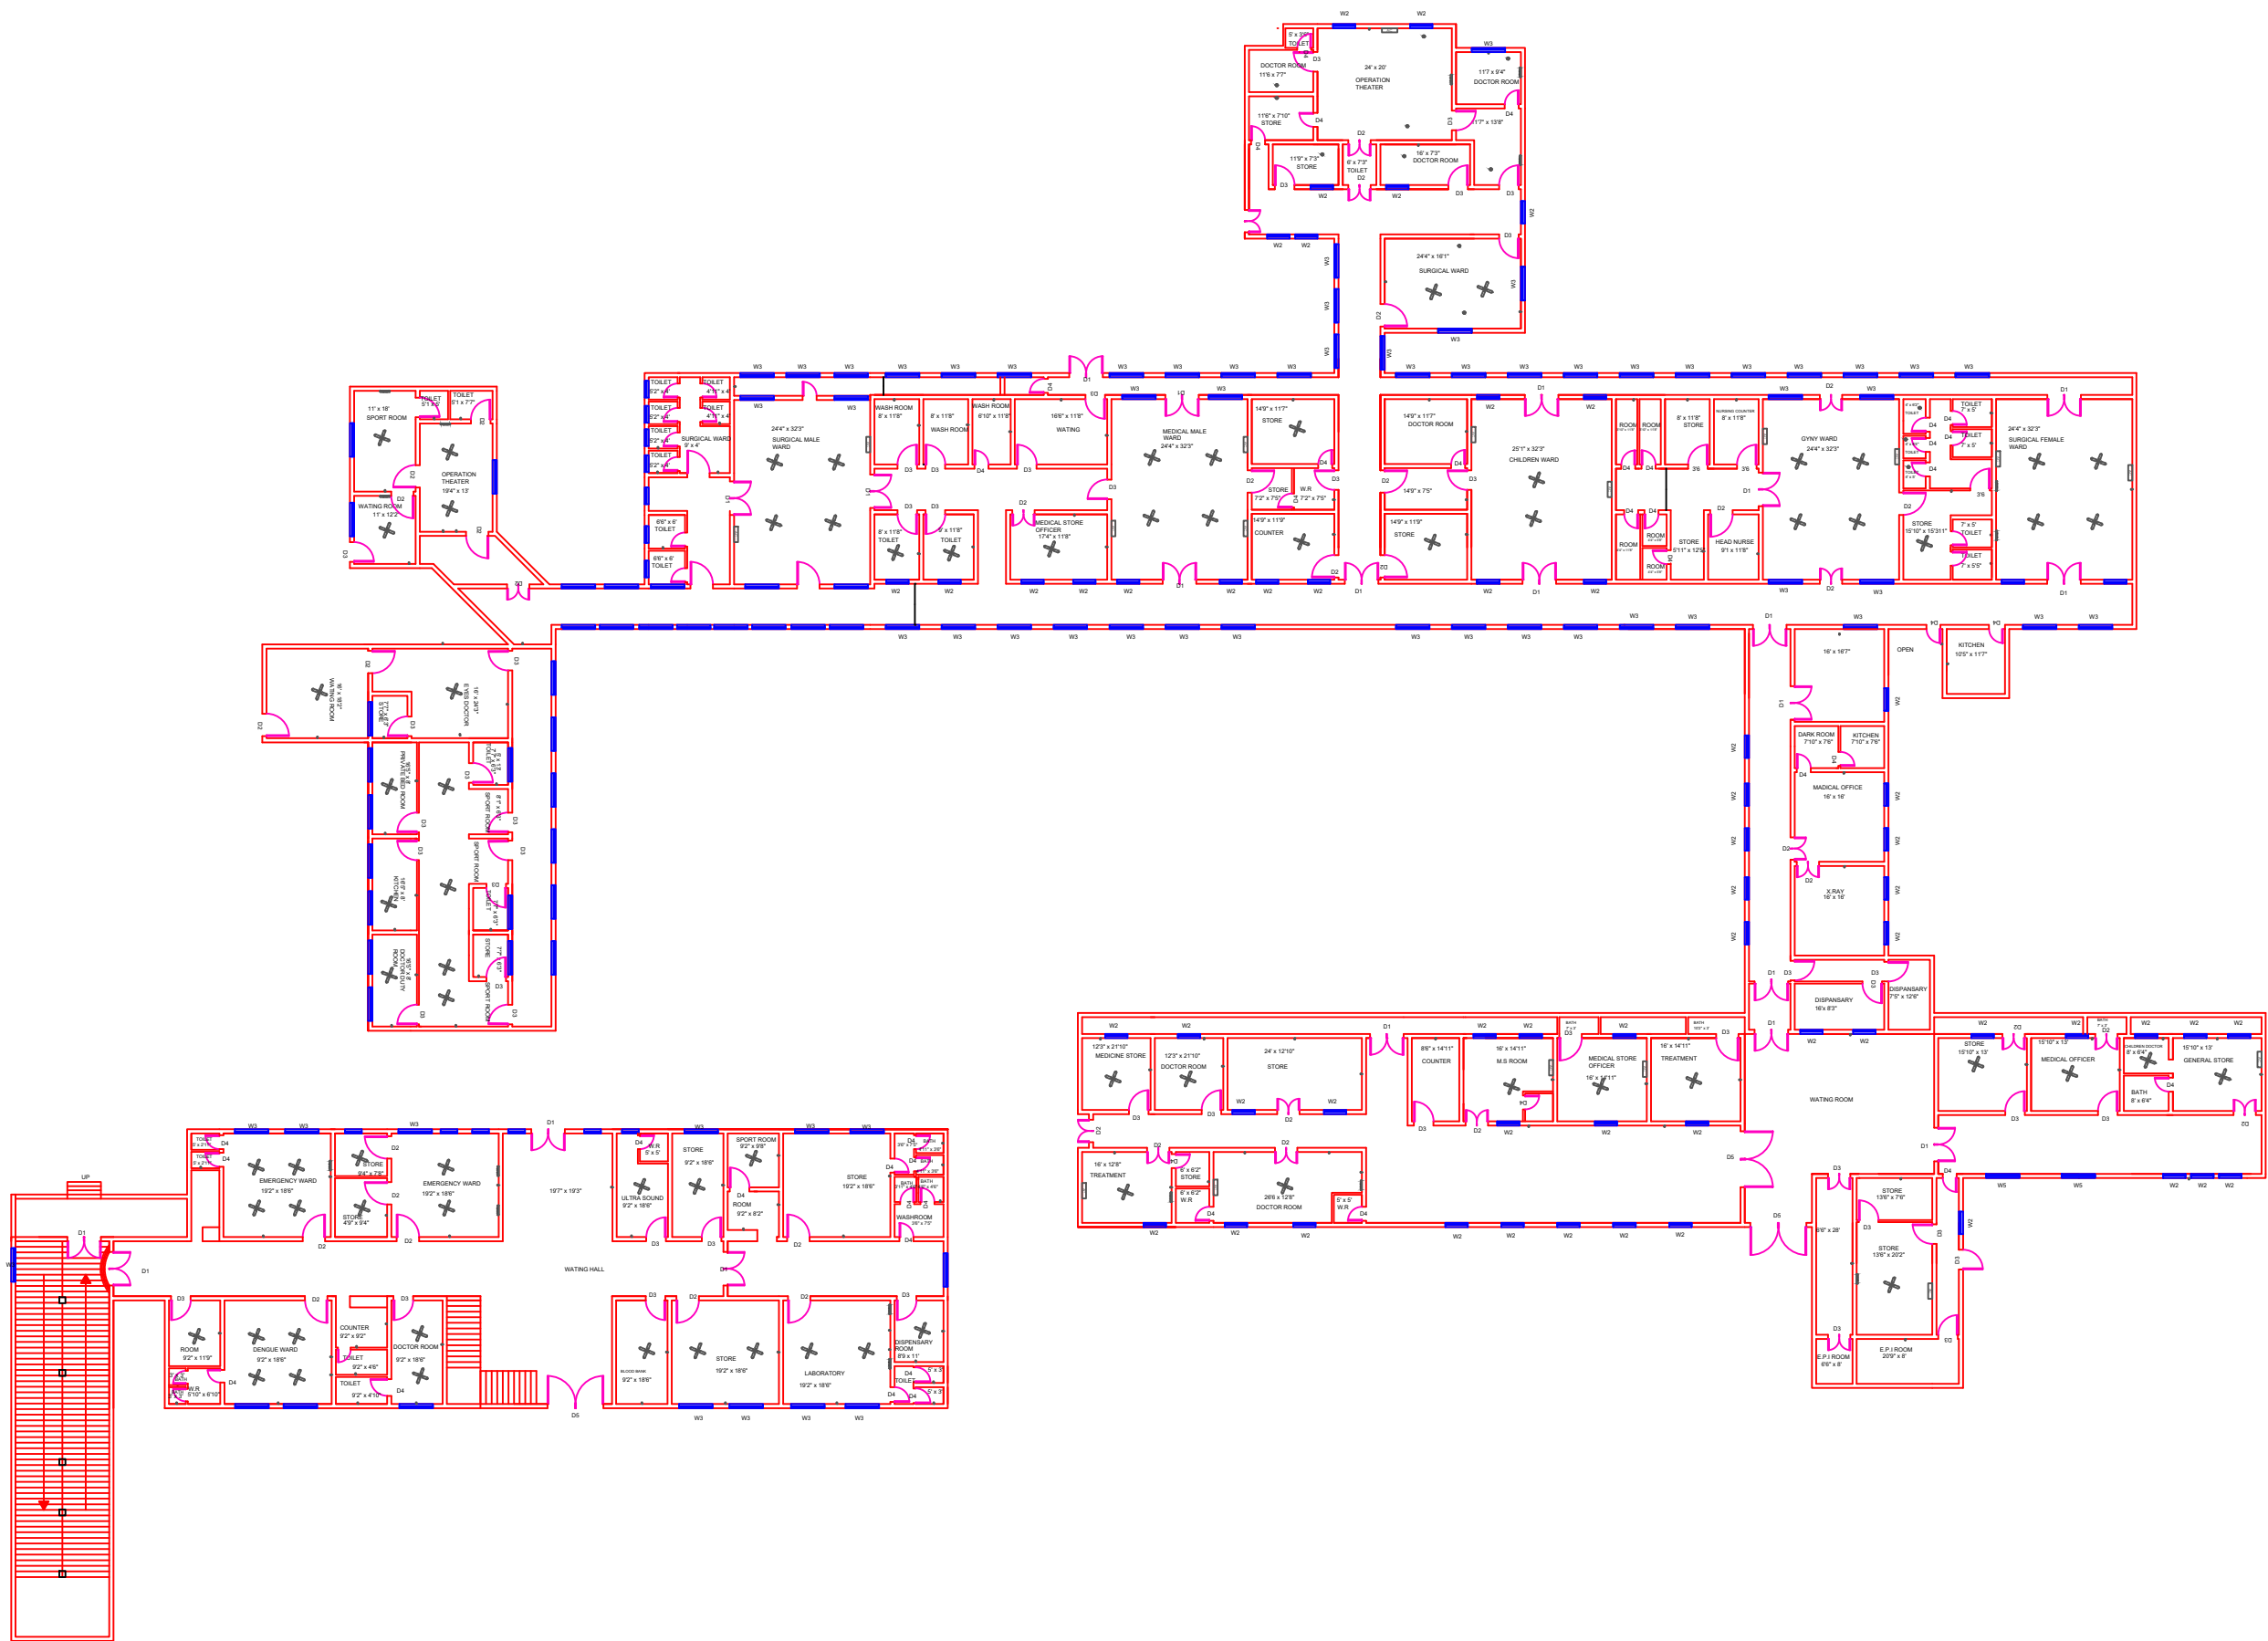

Legends:

Residential Area	
Road	
Wall	
Power Line	
OHT	
Tree	
Man Hole	
Tube Well	
Light Pole	
Lawns	
Earthen Areas	
Asphalts Roads	
Tough Pavers	
P.C.C / Plinth Protection	
Boundary Wall	
Brick Pavers / Soling	
Drain	
Tap	
Hand Pump	
Air Conditioner	
Tube Light	
Fan	
Roof Light	
Bulb	

AREA

AREA WITHIN BOUNDARY WALL	369553.48 Sft
AREA OF CLINICAL BLOCK	46017.03 Sft
PLINTH AREA OF BLOCK	37462.35 Sft

OPENING SCHEDULE OF DOORS AND WINDOWS

DOORS	WIDTH	HEIGHT	WINDOWS	WIDTH	HEIGHT
D1	3'-6"	7'-0"	W1	4'-0"	4'-0"
D2	4'-0"	7'-0"	W2	6'-0"	6'-0"
D4	2'-6"	7'-0"			


Project:
**CAD MAPPING OF TEHSIL
HEAD QUARTER HOSPITALS,
PUNJAB**

Client: GOVERNMENT OF THE PUNJAB PRIMARY & SECONDARY HEALTHCARE DEPARTMENT	Consultant: SKAFS CONSULTANT (Pvt.) Limited ENGINEERING AND ENVIRONMENT CONSULTANT
---	--

Drawing Title:
**THQ KHARIAN
ELECTRICAL PLAN (GROUND FLOOR)**

Drawing No.
SKAFS/KHARIAN /14

ELECTRICAL LAYOUT PLAN OF THQ HOSPITAL KHARIAN FIRST FLOOR

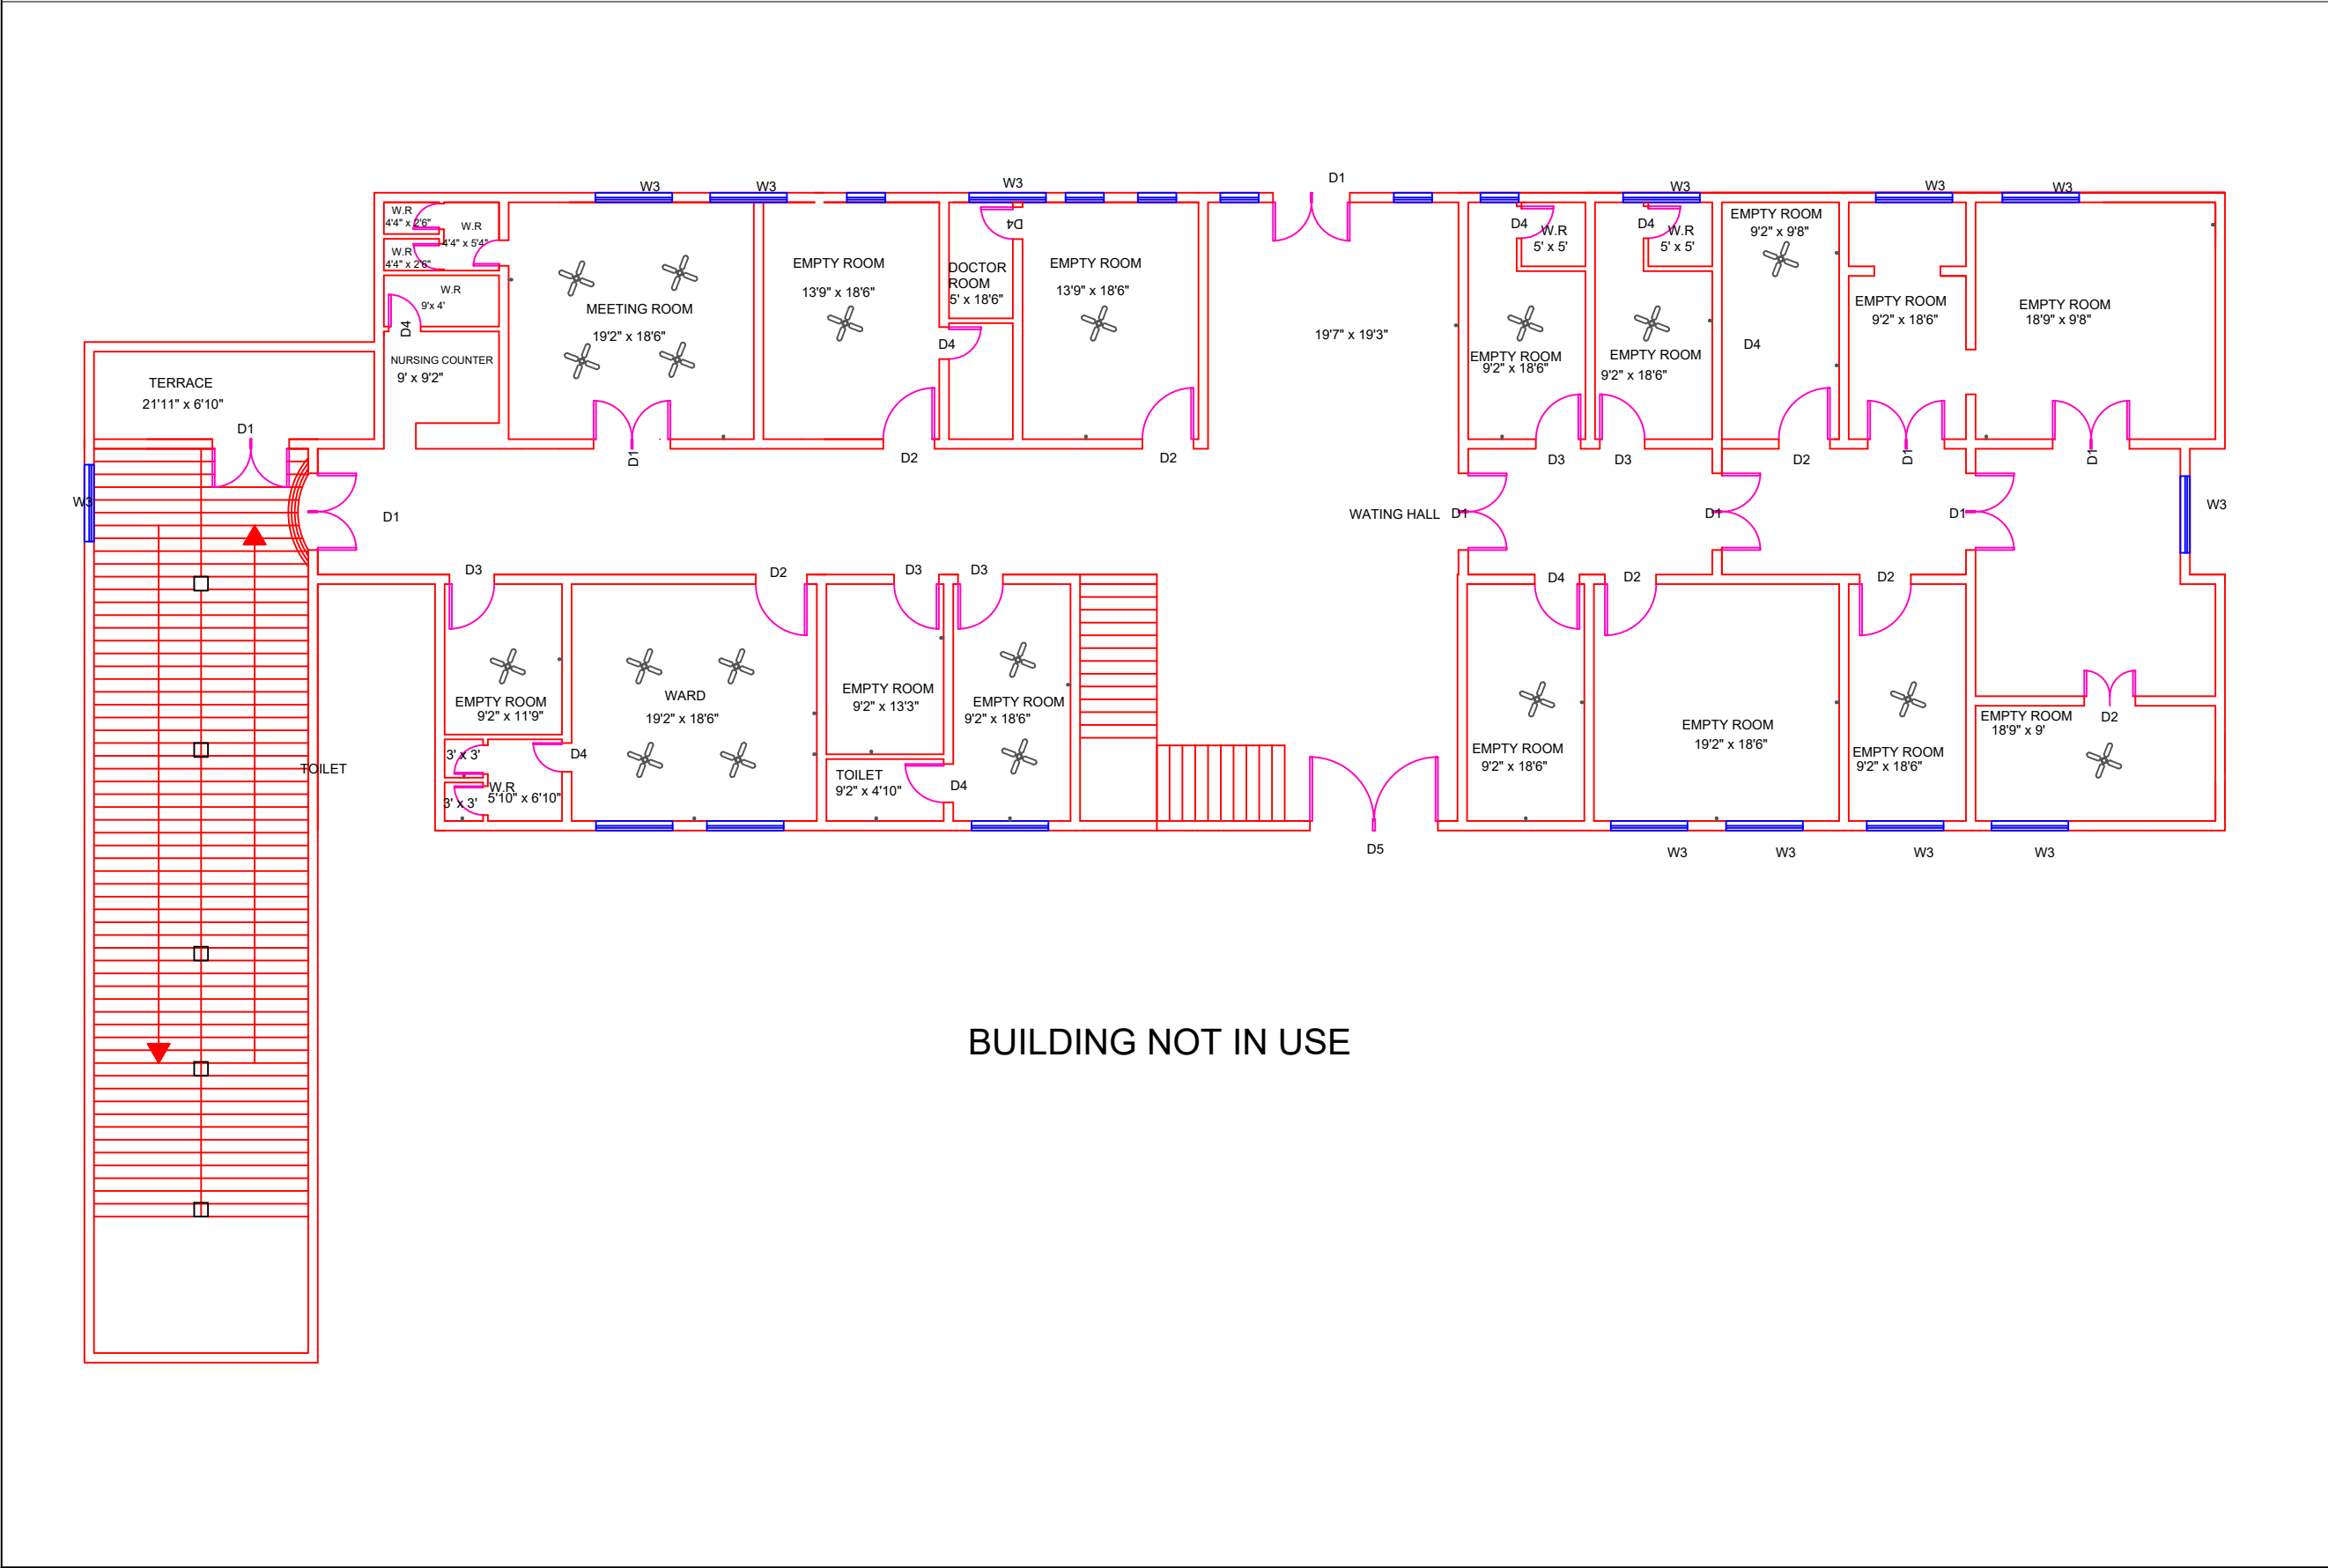

Residential Area	
Road	
Wall	
Power Line	
OHT	
Tree	
Man Hole	
Tube Well	
Light Pole	
Lawns	
Earthen Areas	
Asphalts Roads	
Tough Pavers	
P.C.C / Plinth Protection	
Boundary Wall	
Brick Pavers / Soling	
Drain	
Tap	
Hand Pump	
Air Conditioner	
Tube Light	
Fan	
Roof Light	
Bulb	

[illegible]

Client:  GOVERNMENT OF THE PUNJAB PRIMARY & SECONDARY HEALTHCARE DEPARTMENT	Consultant:  SKAFS CONSULTANT (Pvt.) Limited <i>ENGINEERING AND ENVIRONMENT CONSULTANT</i>
--	---

Drawing No.	SKAFS/KHARIAN /15
-------------	-------------------