


MASTER PLAN OF THQ HOSPITAL KOT MOMIN

PART 1

PART 2

PART 3

PART 4

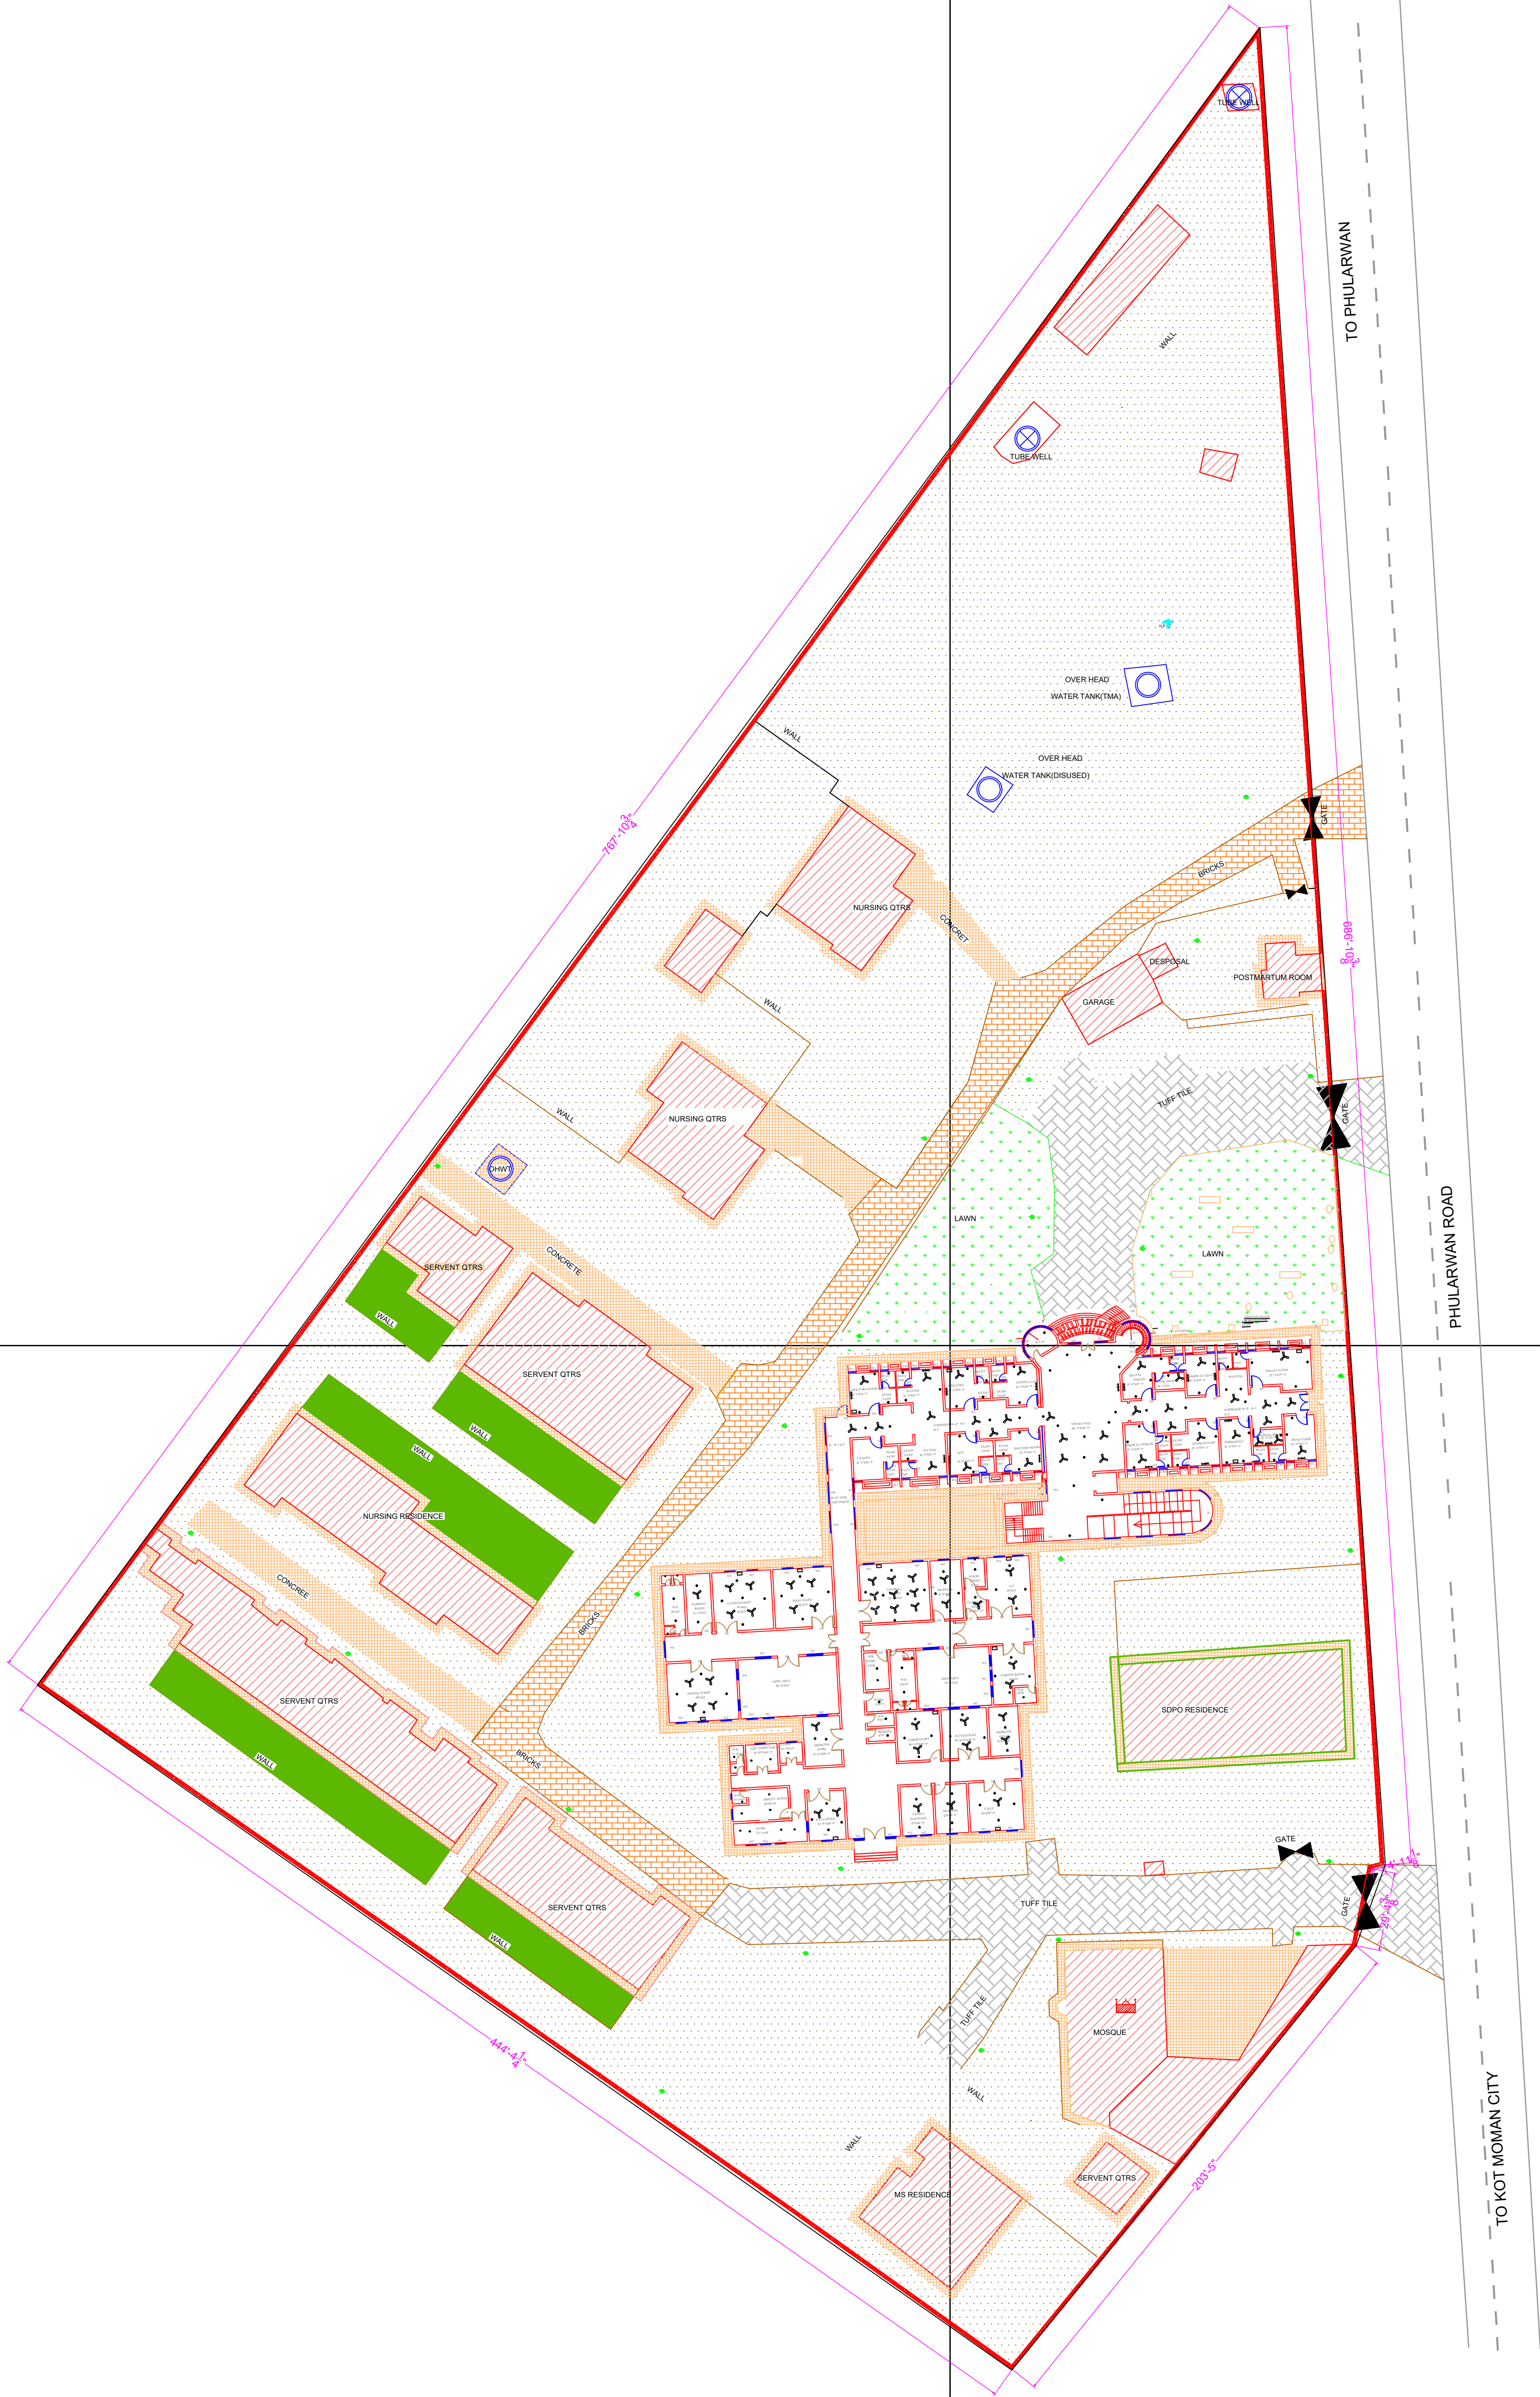

Legends:

RESIDENTIAL AREA	
ROAD	
WALL	
POWER LINE	
OHT	
TREE	
MANHOLE	
TUBE WELL	
LIGHT POLE	
LAWNS	
EARTHEN AREAS	
ASPHALTS ROADS	
TOUGH PAVERS	
P.C.C. /PLINTH PROTECTION	
BOUNDARY WALL	
TAP	
HAND PUMP	
BRICK PAVERS	
AIR CONDITIONER	
TUBE LIGHT	
FAN	
ROOF LIGHT	
BULB	

AREA	
AREA WITHIN BOUNDARY WALL	32248413.6913 SFT
AREA OF CLINICAL BLOCK	18965778.5977 SFT
PLINTH AREA OF BLOCK	13470334.8618 SFT

OPENING SCHEDULE OF DOORS AND WINDOWS					
DOORS	WIDTH	HEIGHT	WINDOWS	WIDTH	HEIGHT
D1	5'-0"	7'-0"	W1	6'-0"	6'-0"
D2	3'-6"	7'-0"	W2	4'-0"	4'-0"
D3	2'-0"	7'-0"	W3	3'-0"	5'-0"
D4	8'-0"	7'-0"	W4	2'-0"	2'-0"
D5			W5		
D6			W6		
D7			W7		
D8			V1		
D9			V2		

Client:



GOVERNMENT OF THE PUNJAB
PRIMARY & SECONDARY
HEALTHCARE DEPARTMENT

Project:

CAD MAPPING OF TEHSIL
HEAD QUARTER HOSPITALS,
PUNJAB

Consultant:



SKAFS CONSULTANT (Pvt.) Limited
ENGINEERING AND ENVIRONMENT CONSULTANT


Drawing Title:

THQ KOTMOMIN
HOSPITAL MASTER PLAN

Authorized By: SKAFS	Reviewed By Co-Team Leader	Scale: 1:400
Prepared By: CAD TEAMS	Date: FEB, 2017	
Drawing No. SKAFS/KOTMOMIN /03		

MASTER PLAN OF THQ HOSPITAL KOT MOMIN

PART 1

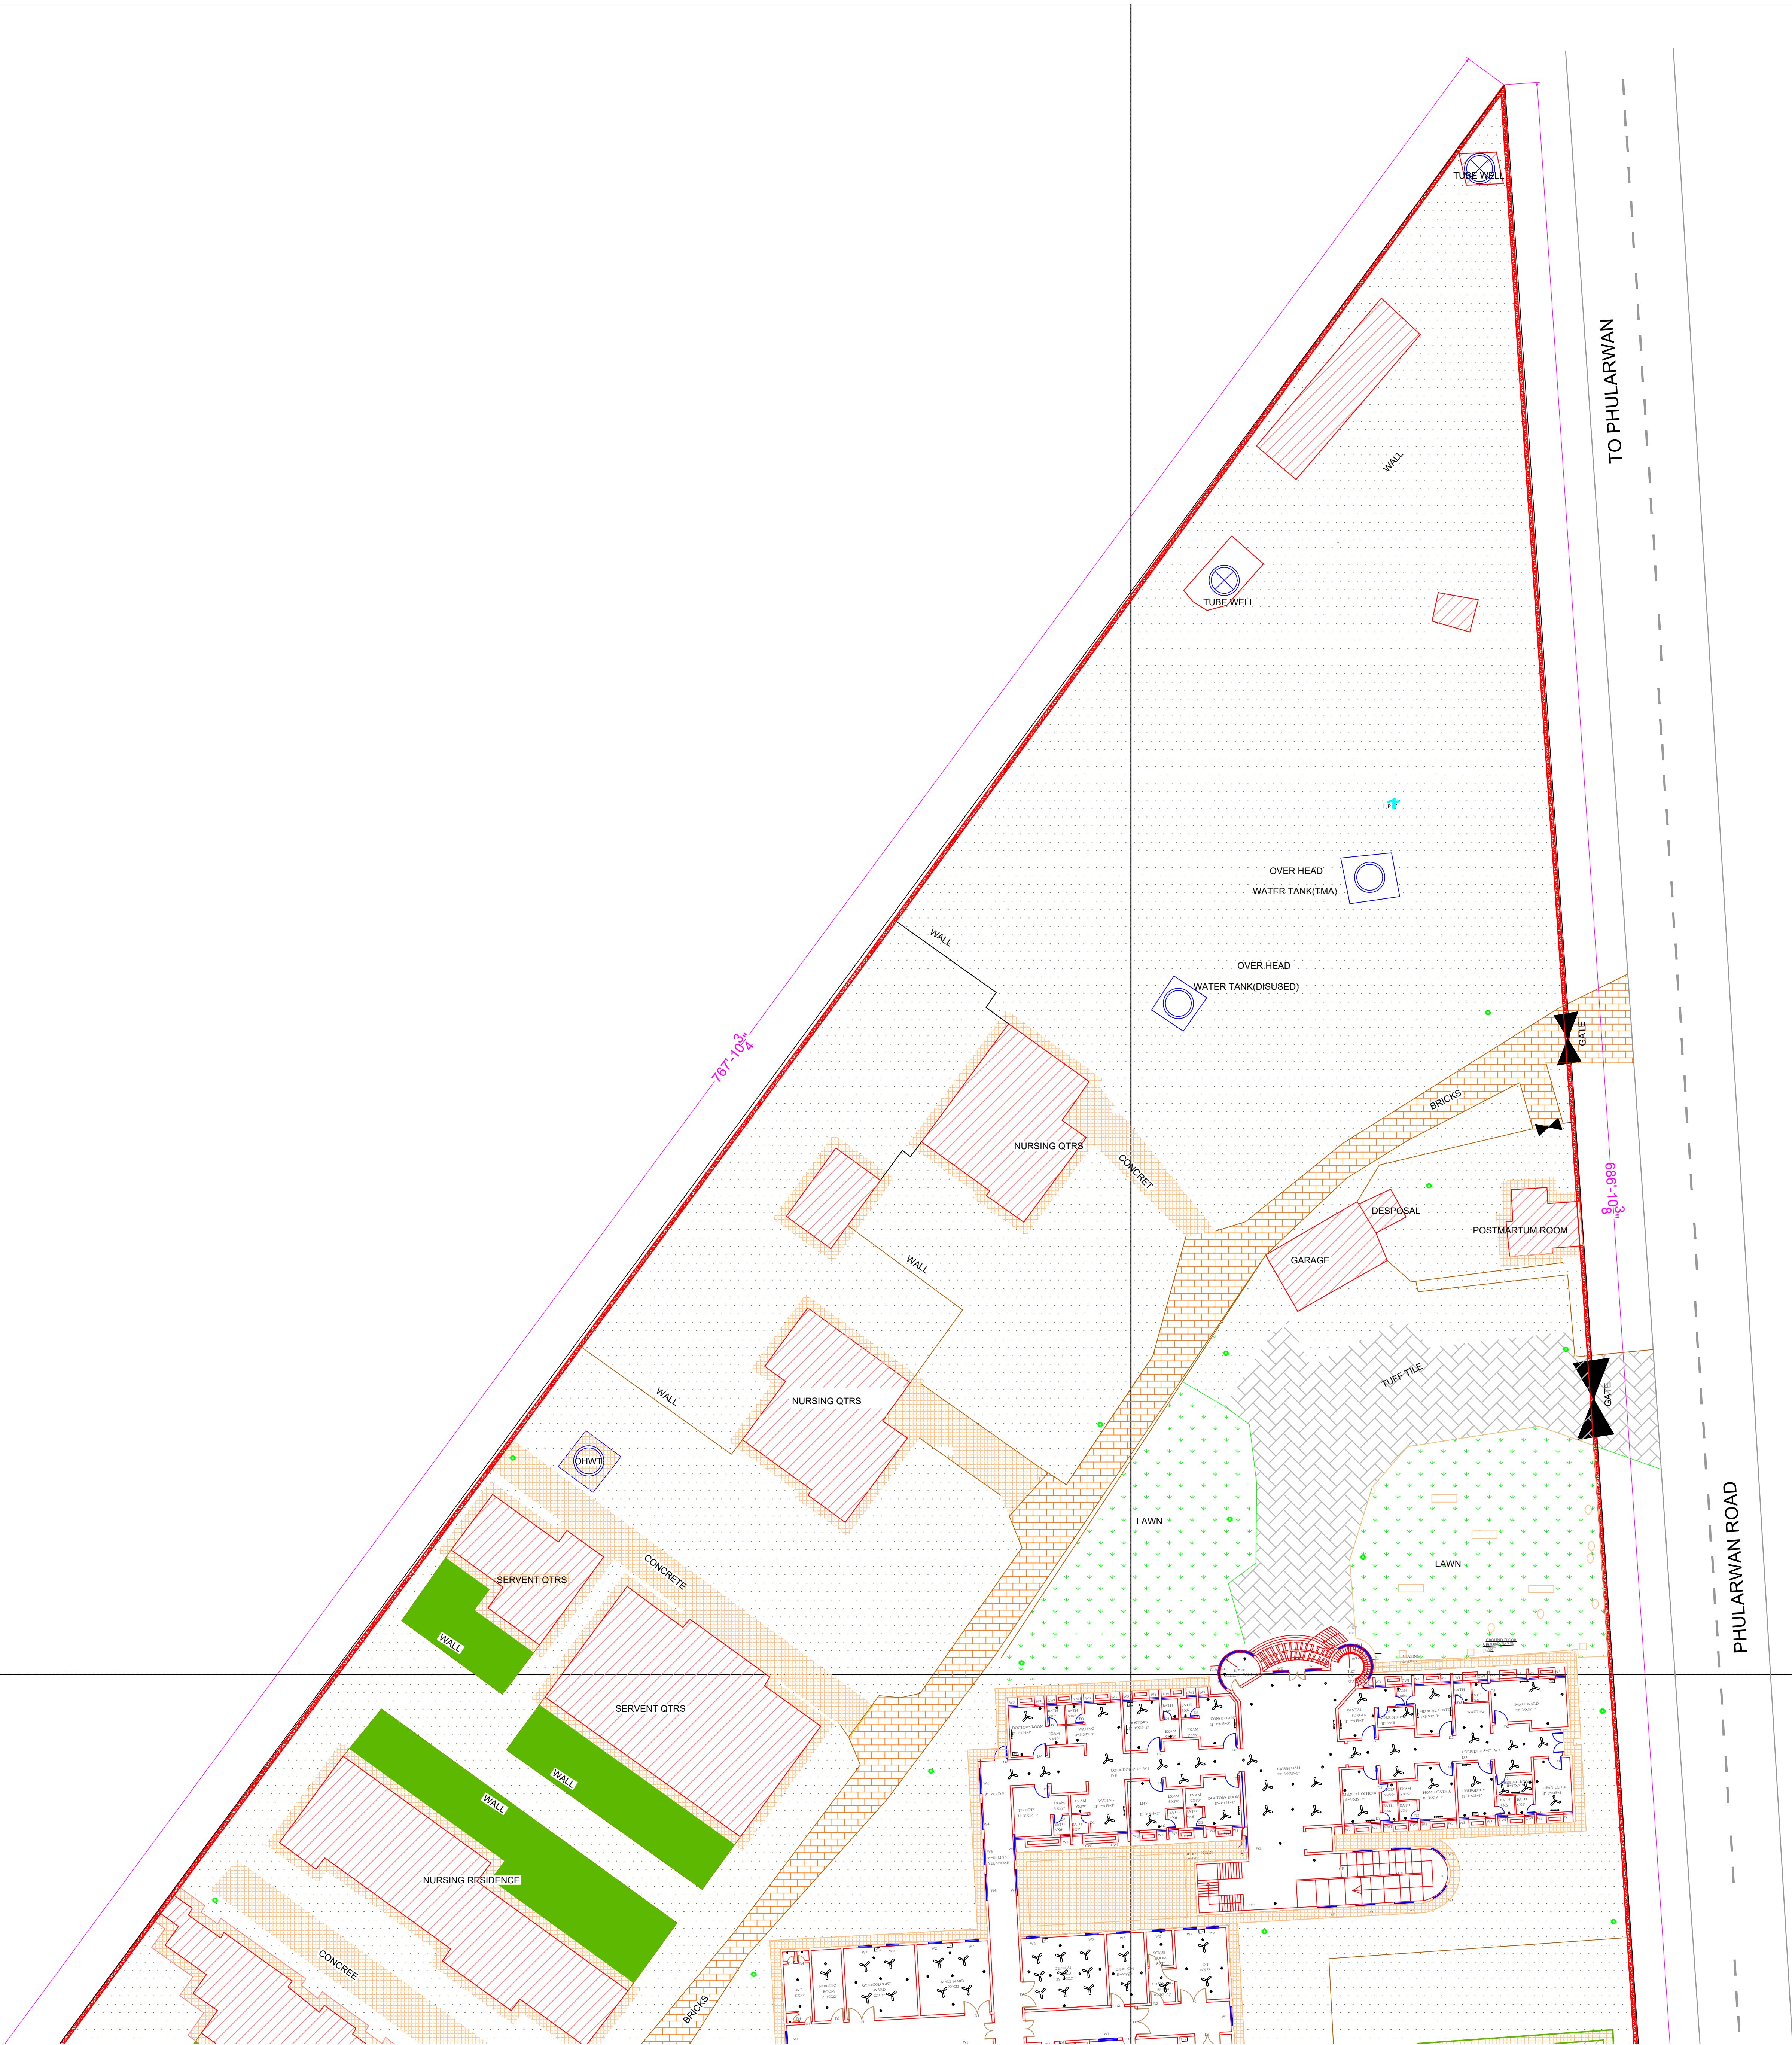

Legends:

RESIDENTIAL AREA	
ROAD	
WALL	
POWER LINE	
OHT	
TREE	
MANHOLE	
TUBE WELL	
LIGHT POLE	
LAWNS	
EARTHEN AREAS	
ASPHALTS ROADS	
TOUGH PAVERS	
P.C.C /PLINTH PROTECTION	
BOUNDARY WALL	
TAP	
HAND PUMP	
BRICK PAVERS	
AIR CONDITIONER	
TUBE LIGHT	
FAN	
ROOF LIGHT	
BULB	

AREA	
AREA WITHIN BOUNDARY WALL	32248413.6913 SFT
AREA OF CLINICAL BLOCK	18965778.5977 SFT
PLINTH AREA OF BLOCK	13470334.8618 SFT

OPENING SCHEDULE OF DOORS AND WINDOWS					
DOORS	WIDTH	HEIGHT	WINDOWS	WIDTH	HEIGHT
D1	5'-0"	7'-0"	W1	6'-0"	6'-0"
D2	3'-6"	7'-0"	W2	4'-0"	4'-0"
D3	2'-0"	7'-0"	W3	3'-0"	5'-0"
D4	8'-0"	7'-0"	W4	2'-0"	2'-0"
D5			W5		
D6			W6		
D7			W7		
D8			V1		
D9			V2		

Client:



GOVERNMENT OF THE PUNJAB
PRIMARY & SECONDARY
HEALTHCARE DEPARTMENT

Project:

CAD MAPPING OF TEHSIL
HEAD QUARTER HOSPITALS,
PUNJAB

Consultant:



SKAFS CONSULTANT (Pvt.) Limited
ENGINEERING AND ENVIRONMENT CONSULTANT


Drawing Title:

THQ KOTMOMIN
HOSPITAL MASTER PLAN
PART 1

Authorized By: SKAFS	Reviewed By Co-Team Leader	Scale:
Prepared By: CAD TEAMS	Date: FEB, 2017	Sheet:
Drawing No.		SKAFS/KOTMOMIN /04

MASTER PLAN OF THQ HOSPITAL KOT MOMIN

PART 2

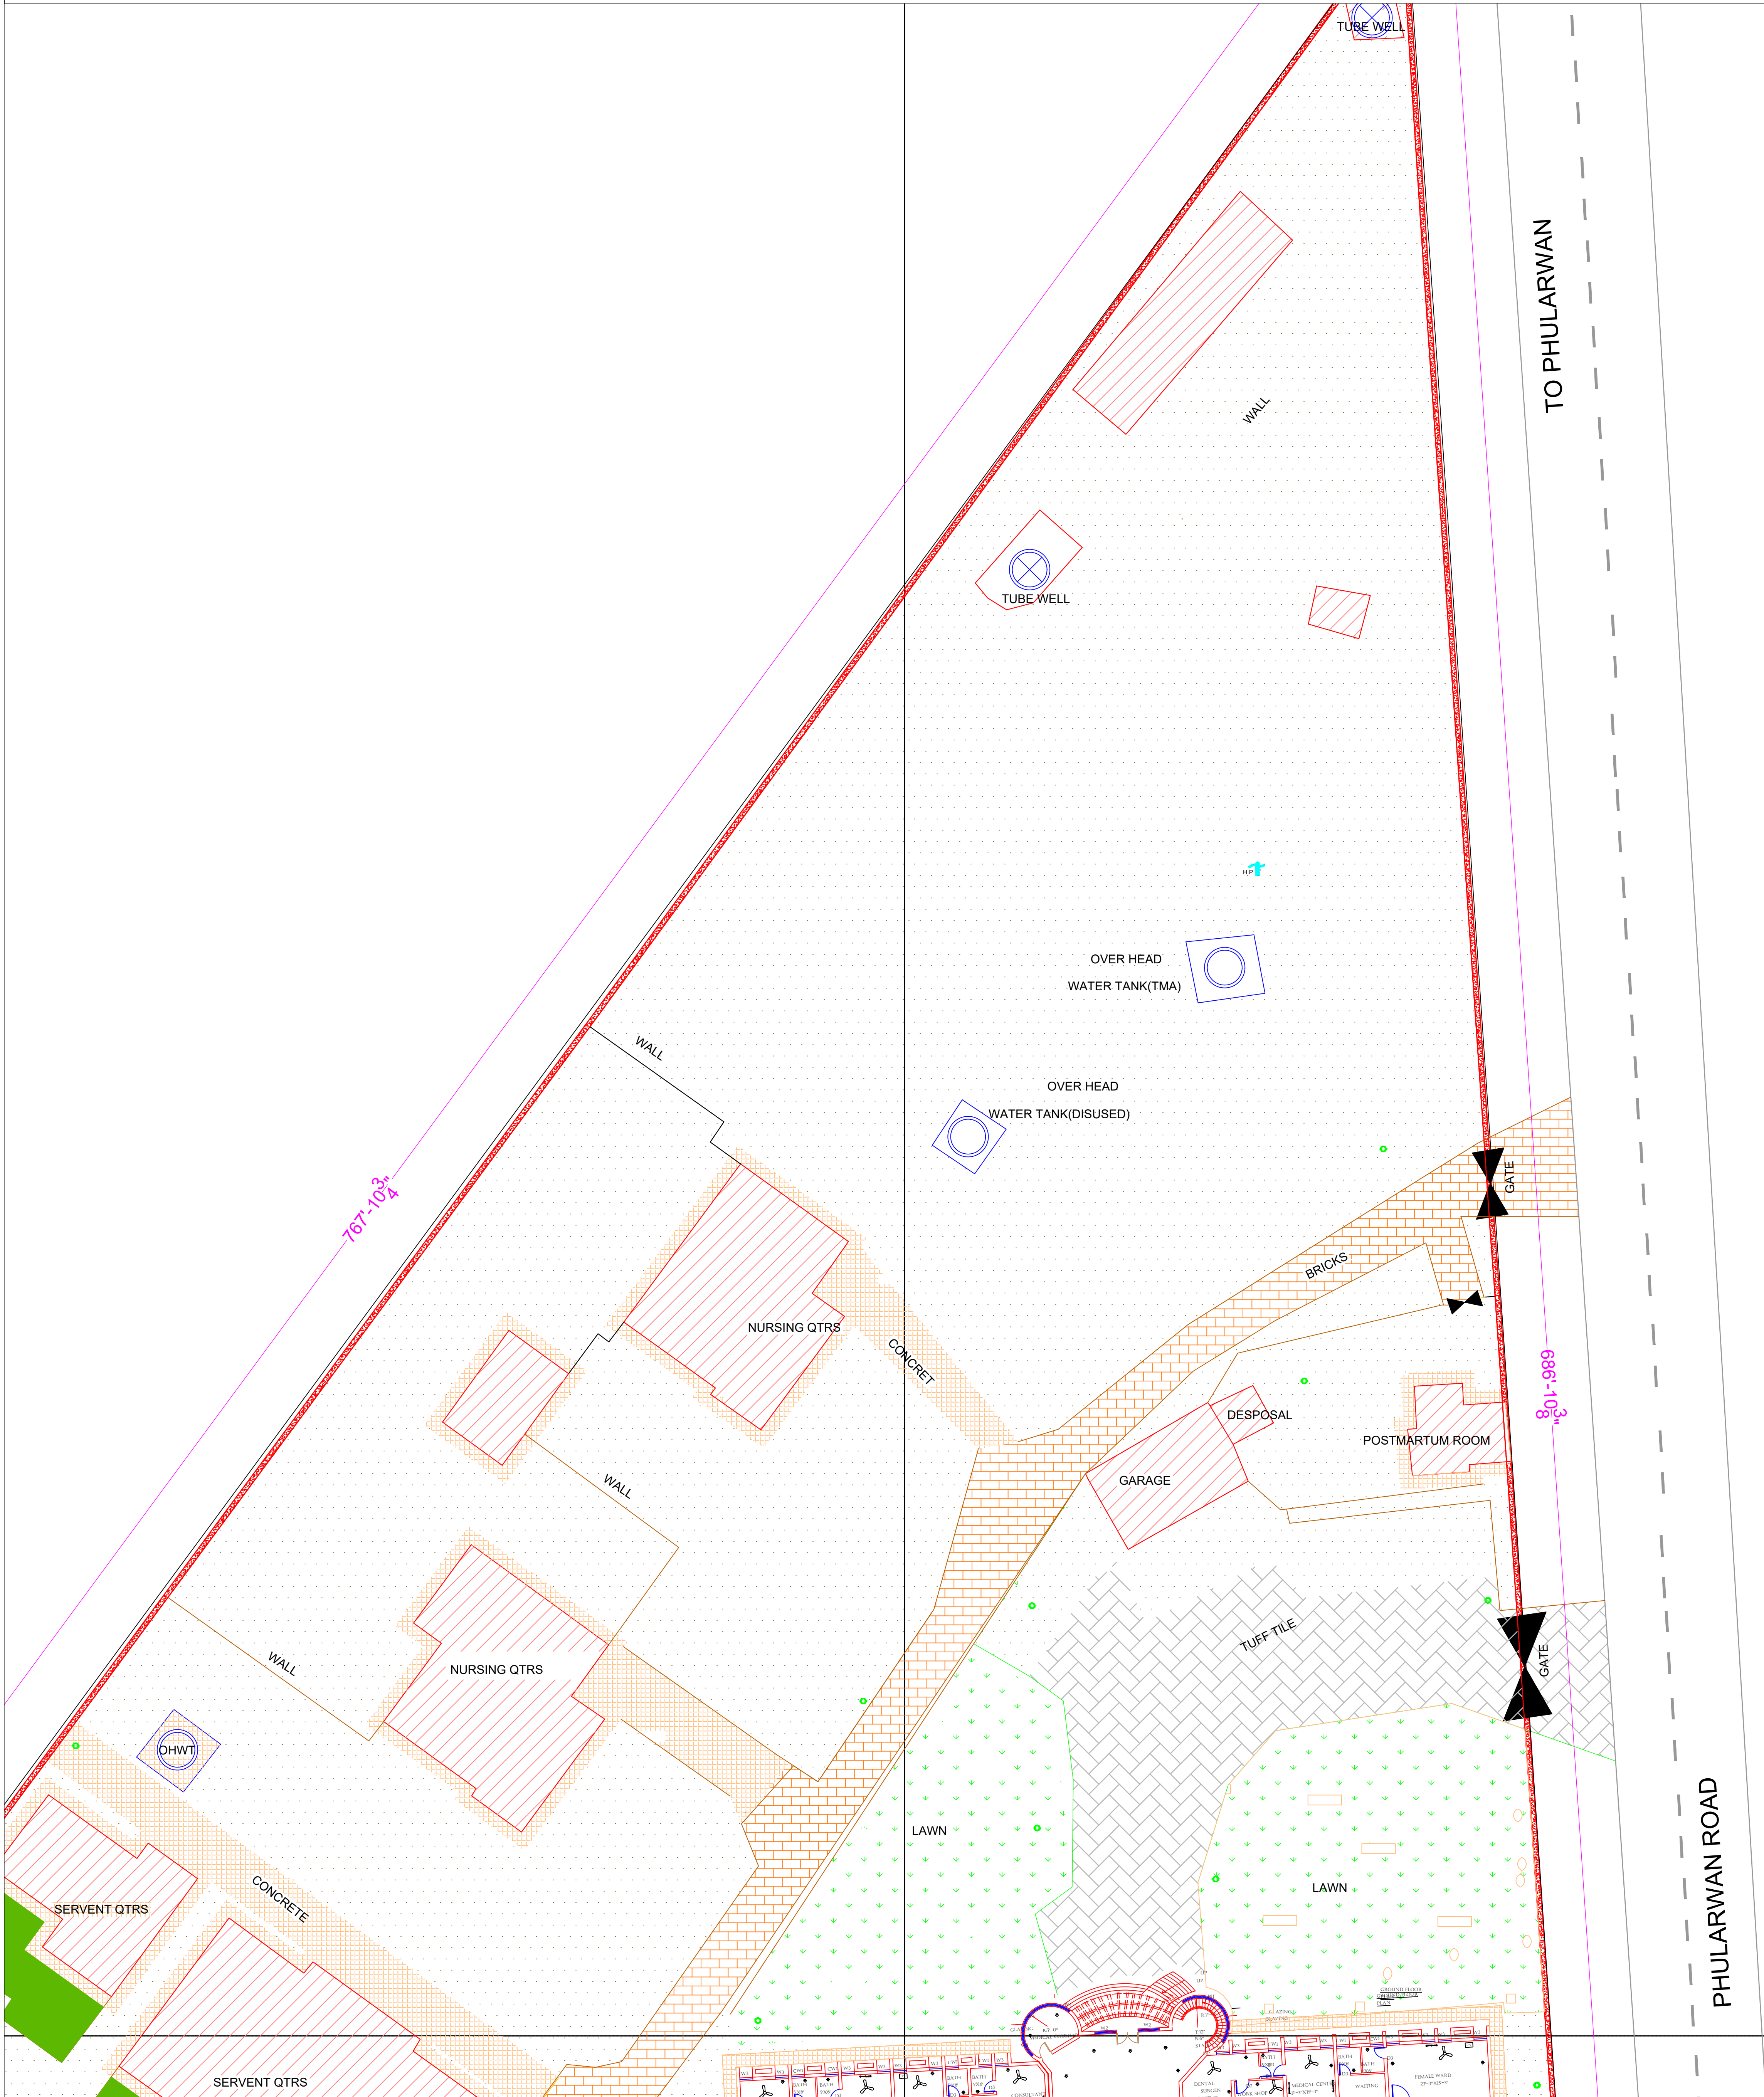

Legends:

RESIDENTIAL AREA	
ROAD	
WALL	
POWER LINE	
OHT	
TREE	
MANHOLE	
TUBE WELL	
LIGHT POLE	
LAWNS	
EARTHEN AREAS	
ASPHALTS ROADS	
TOUGH PAVERS	
P.C.C /PLINTH PROTECTION	
BOUNDARY WALL	
TAP	
HAND PUMP	
BRICK PAVERS	
AIR CONDITIONER	
TUBE LIGHT	
FAN	
ROOF LIGHT	
BULB	

AREA	
AREA WITHIN BOUNDARY WALL	32248413.6913 SFT
AREA OF CLINICAL BLOCK	18965778.5977 SFT
PLINTH AREA OF BLOCK	13470334.8618 SFT

OPENING SCHEDULE OF DOORS AND WINDOWS					
DOORS	WIDTH	HEIGHT	WINDOWS	WIDTH	HEIGHT
D1	5'-0"	7'-0"	W1	6'-0"	6'-0"
D2	3'-6"	7'-0"	W2	4'-0"	4'-0"
D3	2'-0"	7'-0"	W3	3'-0"	5'-0"
D4	8'-0"	7'-0"	W4	2'-0"	2'-0"
D5			W5		
D6			W6		
D7			W7		
D8			V1		
D9			V2		

Client:



GOVERNMENT OF THE PUNJAB
PRIMARY & SECONDARY
HEALTHCARE DEPARTMENT

Project:

CAD MAPPING OF TEHSIL
HEAD QUARTER HOSPITALS,
PUNJAB

Consultant:



SKAFS CONSULTANT (Pvt.) Limited
ENGINEERING AND ENVIRONMENT CONSULTANT

Drawing Title:

THQ KOTMOMIN
HOSPITAL MASTER PLAN
PART 2

Authorized By: SKAFS	Reviewed By Co-Team Leader	Scale:
-------------------------	-------------------------------	--------


Prepared By: CAD TEAMS	Date: FEB, 2017	Sheet:
---------------------------	--------------------	--------

Drawing No.

SKAFS/KOTMOMIN /05

MASTER PLAN OF THQ HOSPITAL KOT MOMIN

PART 3

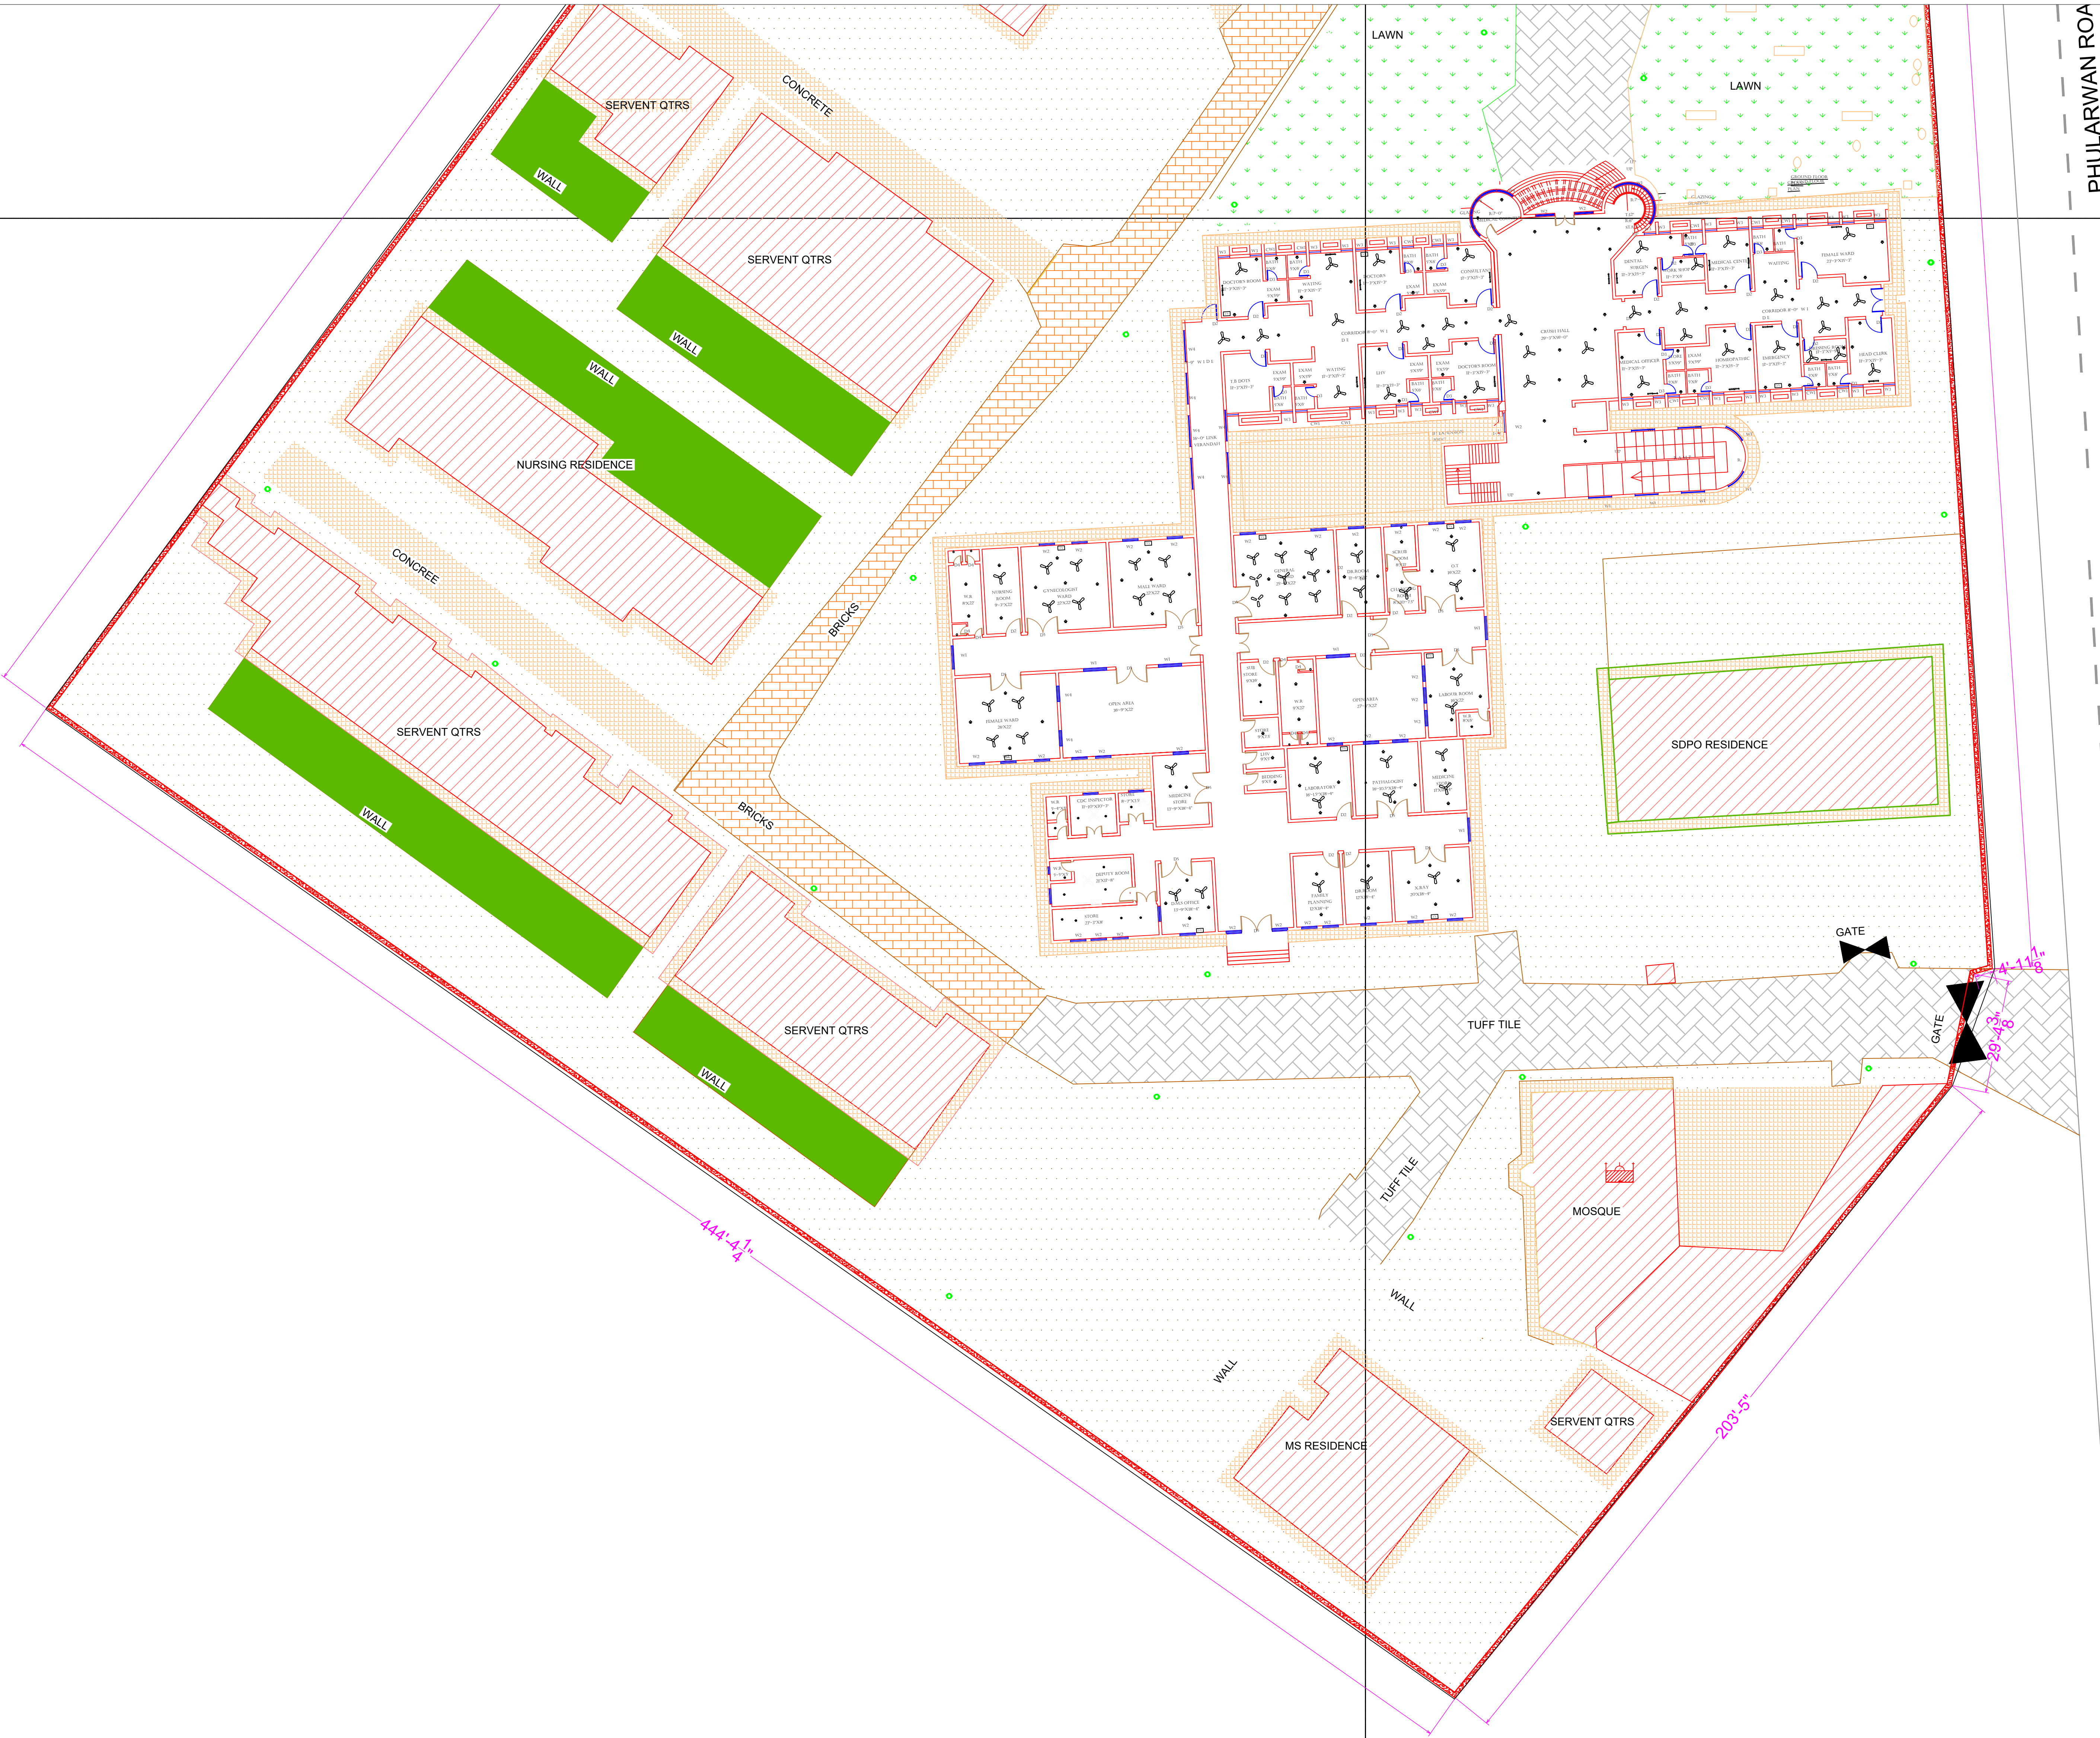

Legends:

RESIDENTIAL AREA	
ROAD	
WALL	
POWER LINE	
OHT	
TREE	
MANHOLE	
TUBE WELL	
LIGHT POLE	
LAWNS	
EARTHEN AREAS	
ASPHALTS ROADS	
TOUGH PAVERS	
P.C.C /PLINTH PROTECTION	
BOUNDARY WALL	
TAP	
HAND PUMP	
BRICK PAVERS	
AIR CONDITIONER	
TUBE LIGHT	
FAN	
ROOF LIGHT	
BULB	

AREA	
AREA WITHIN BOUNDARY WALL	32248413.6913 SFT
AREA OF CLINICAL BLOCK	18965778.5977 SFT
PLINTH AREA OF BLOCK	13470334.8618 SFT

OPENING SCHEDULE OF DOORS AND WINDOWS					
DOORS	WIDTH	HEIGHT	WINDOWS	WIDTH	HEIGHT
D1	5'-0"	7'-0"	W1	6'-0"	6'-0"
D2	3'-6"	7'-0"	W2	4'-0"	4'-0"
D3	2'-0"	7'-0"	W3	3'-0"	5'-0"
D4	8'-0"	7'-0"	W4	2'-0"	2'-0"
D5			W5		
D6			W6		
D7			W7		
D8			V1		
D9			V2		

Client:



GOVERNMENT OF THE PUNJAB
PRIMARY & SECONDARY
HEALTHCARE DEPARTMENT

Project:

CAD MAPPING OF TEHSIL
HEAD QUARTER HOSPITALS,
PUNJAB

Consultant:



SKAFS CONSULTANT (Pvt.) Limited
ENGINEERING AND ENVIRONMENT CONSULTANT


Drawing Title:

THQ KOTMOMIN
HOSPITAL MASTER PLAN
PART 3

Authorized By: SKAFS	Reviewed By Co-Team Leader	Scale:
Prepared By: CAD TEAMS	Date: FEB, 2017	
Drawing No.		SKAFS/KOTMOMIN /06

MASTER PLAN OF THQ HOSPITAL KOT MOMIN

PART 4

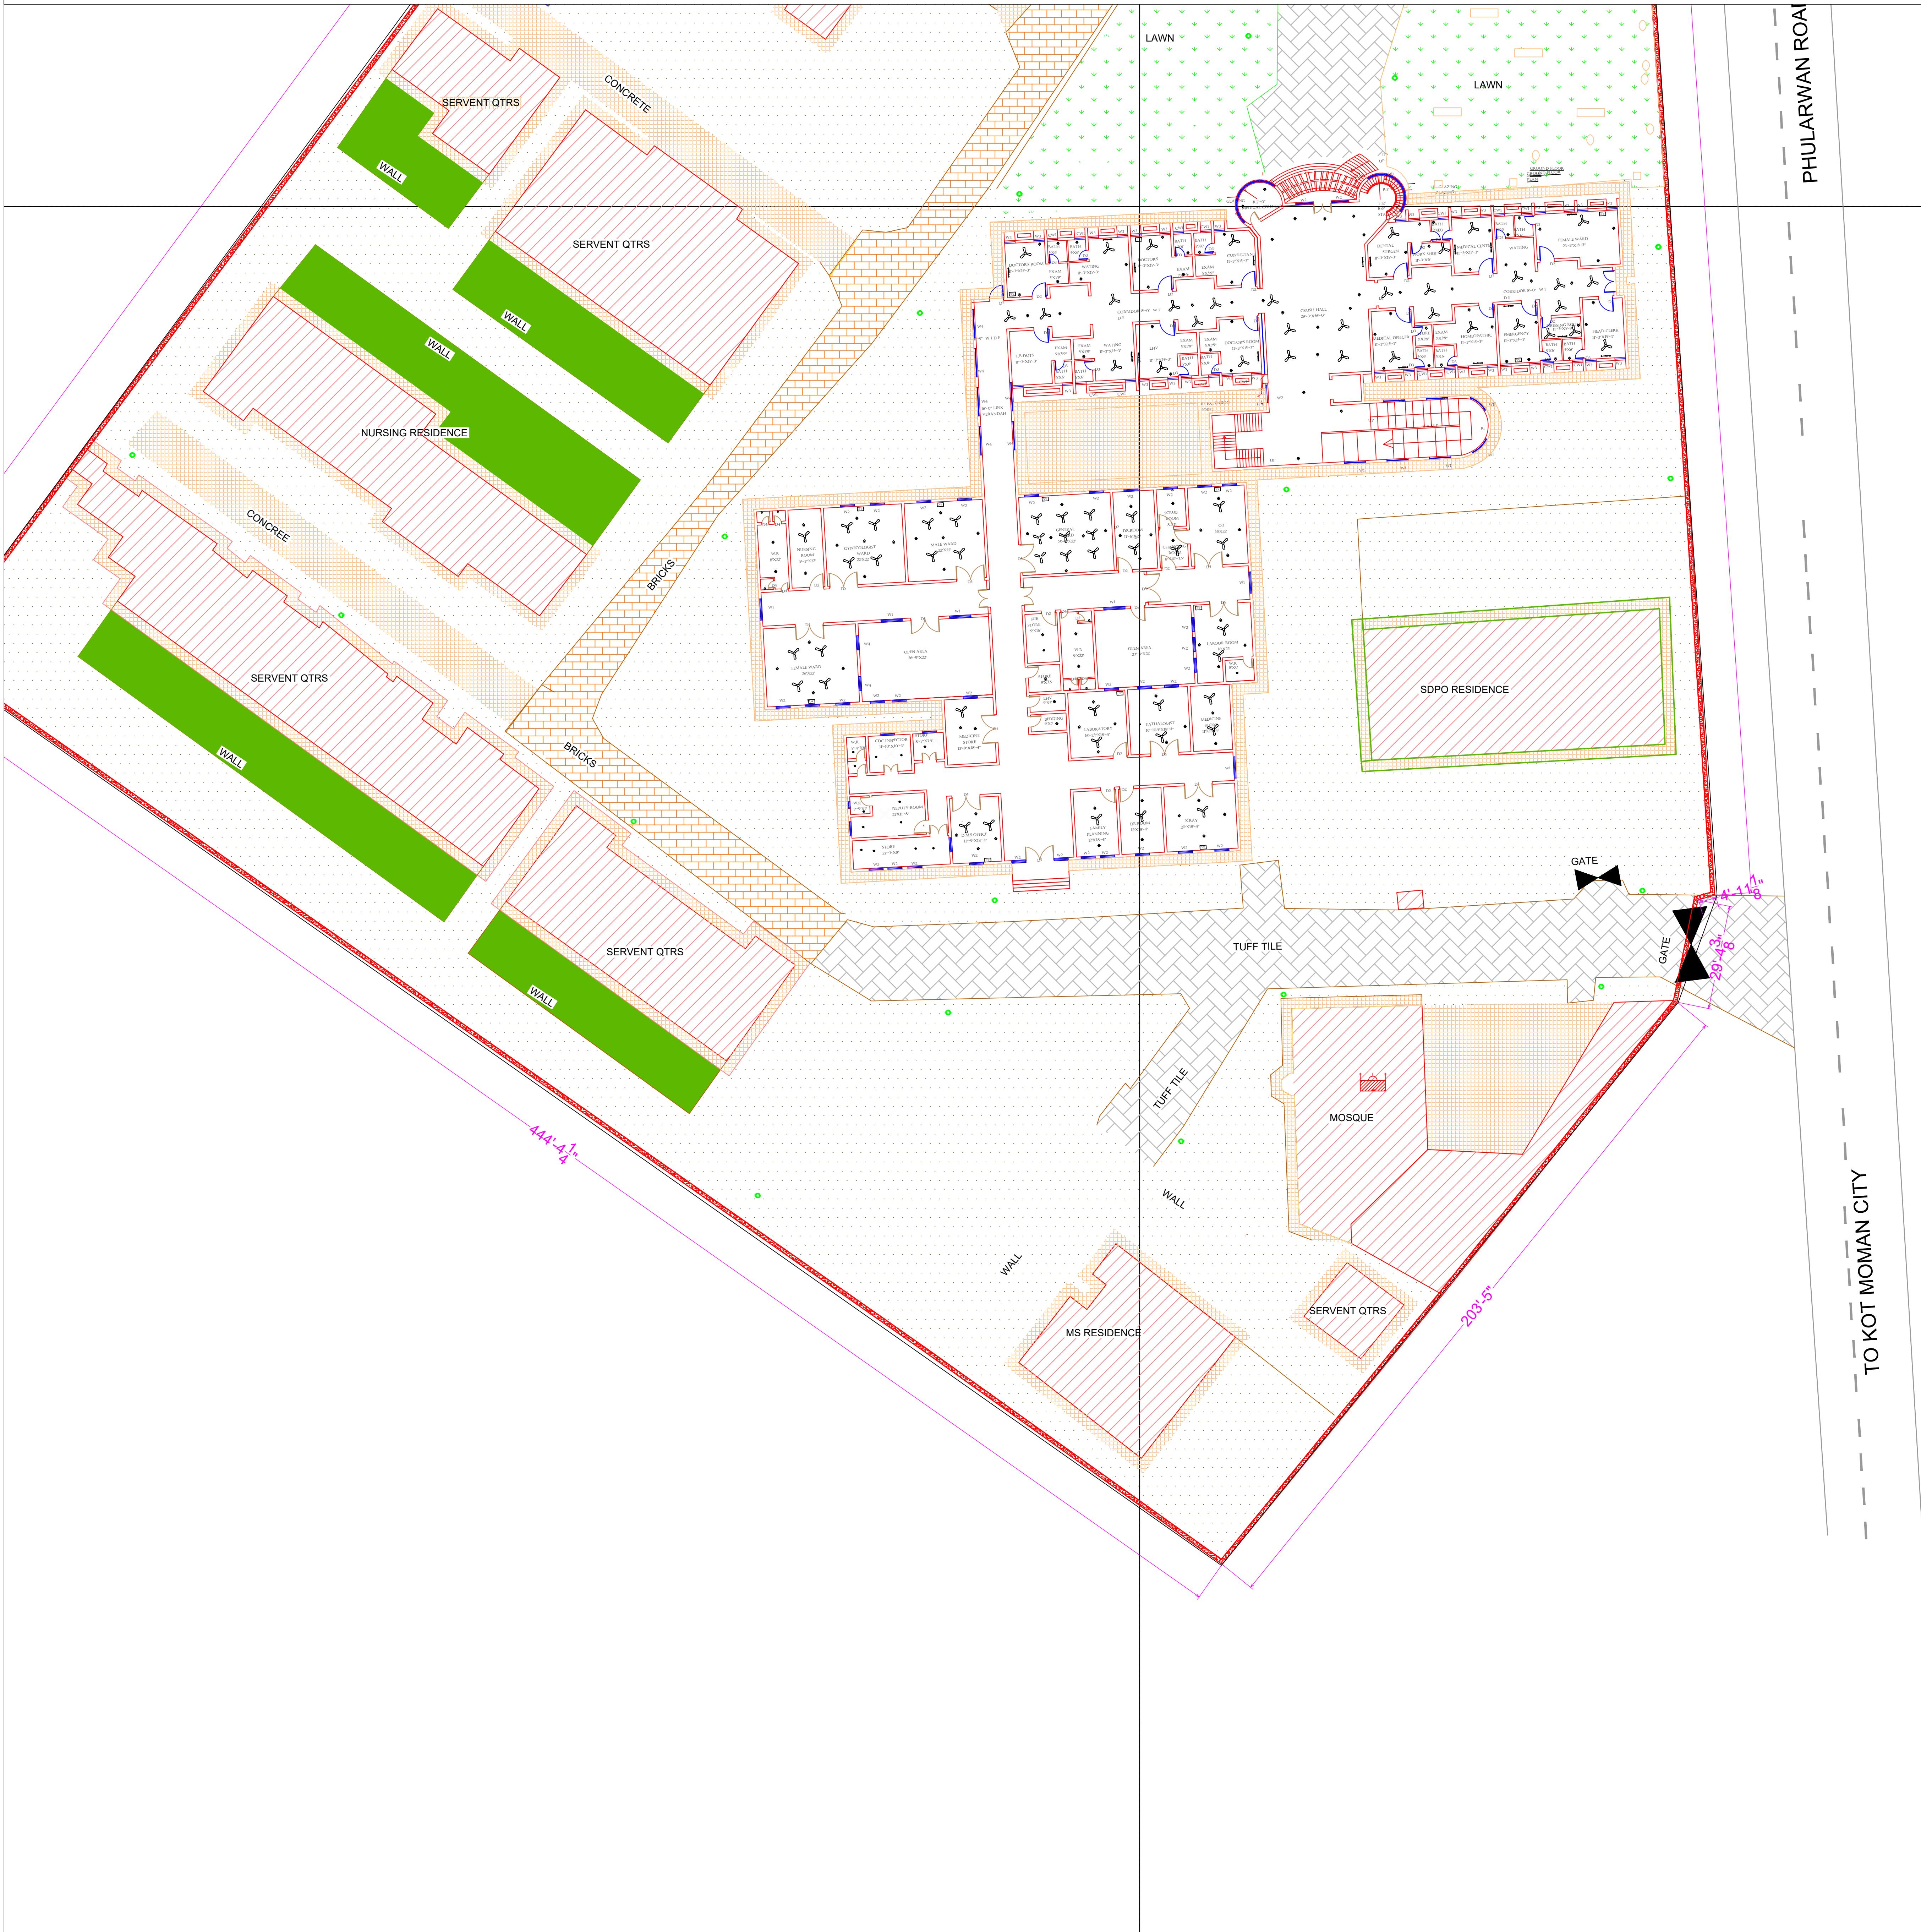

Legends:

RESIDENTIAL AREA	
ROAD	
WALL	
POWER LINE	
OHT	
TREE	
MANHOLE	
TUBE WELL	
LIGHT POLE	
LAWNS	
EARTHEN AREAS	
ASPHALTS ROADS	
TOUGH PAVERS	
P.C.C /PLINTH PROTECTION	
BOUNDARY WALL	
TAP	
HAND PUMP	
BRICK PAVERS	
AIR CONDITIONER	
TUBE LIGHT	
FAN	
ROOF LIGHT	
BULB	

AREA	
AREA WITHIN BOUNDARY WALL	32248413.6913 SFT
AREA OF CLINICAL BLOCK	18965778.5977 SFT
PLINTH AREA OF BLOCK	13470334.8618 SFT

OPENING SCHEDULE OF DOORS AND WINDOWS					
DOORS	WIDTH	HEIGHT	WINDOWS	WIDTH	HEIGHT
D1	5'-0"	7'-0"	W1	6'-0"	6'-0"
D2	3'-6"	7'-0"	W2	4'-0"	4'-0"
D3	2'-0"	7'-0"	W3	3'-0"	5'-0"
D4	8'-0"	7'-0"	W4	2'-0"	2'-0"
D5			W5		
D6			W6		
D7			W7		
D8			V1		
D9			V2		

Client:

GOVERNMENT OF THE PUNJAB
PRIMARY & SECONDARY
HEALTHCARE DEPARTMENT

Project:

**CAD MAPPING OF TEHSIL
HEAD QUARTER HOSPITALS,
PUNJAB**

Consultant:

SKAFS CONSULTANT (Pvt.) Limited
ENGINEERING AND ENVIRONMENT CONSULTANT

Drawing Title:

**THQ KOTMOMIN
HOSPITAL MASTER PLAN
PART 4**

Authorized By: SKAFS	Reviewed By Co-Team Leader	Scale:
Prepared By: CAD TEAMS	Date: FEB, 2017	

Drawing No.

SKAFS/KOTMOMIN /07

CLINICAL BLOCK OF THQ HOSPITAL KOT MOMIN


GROUND FLOOR

PART 1

PART 2

PART 3

PART 4

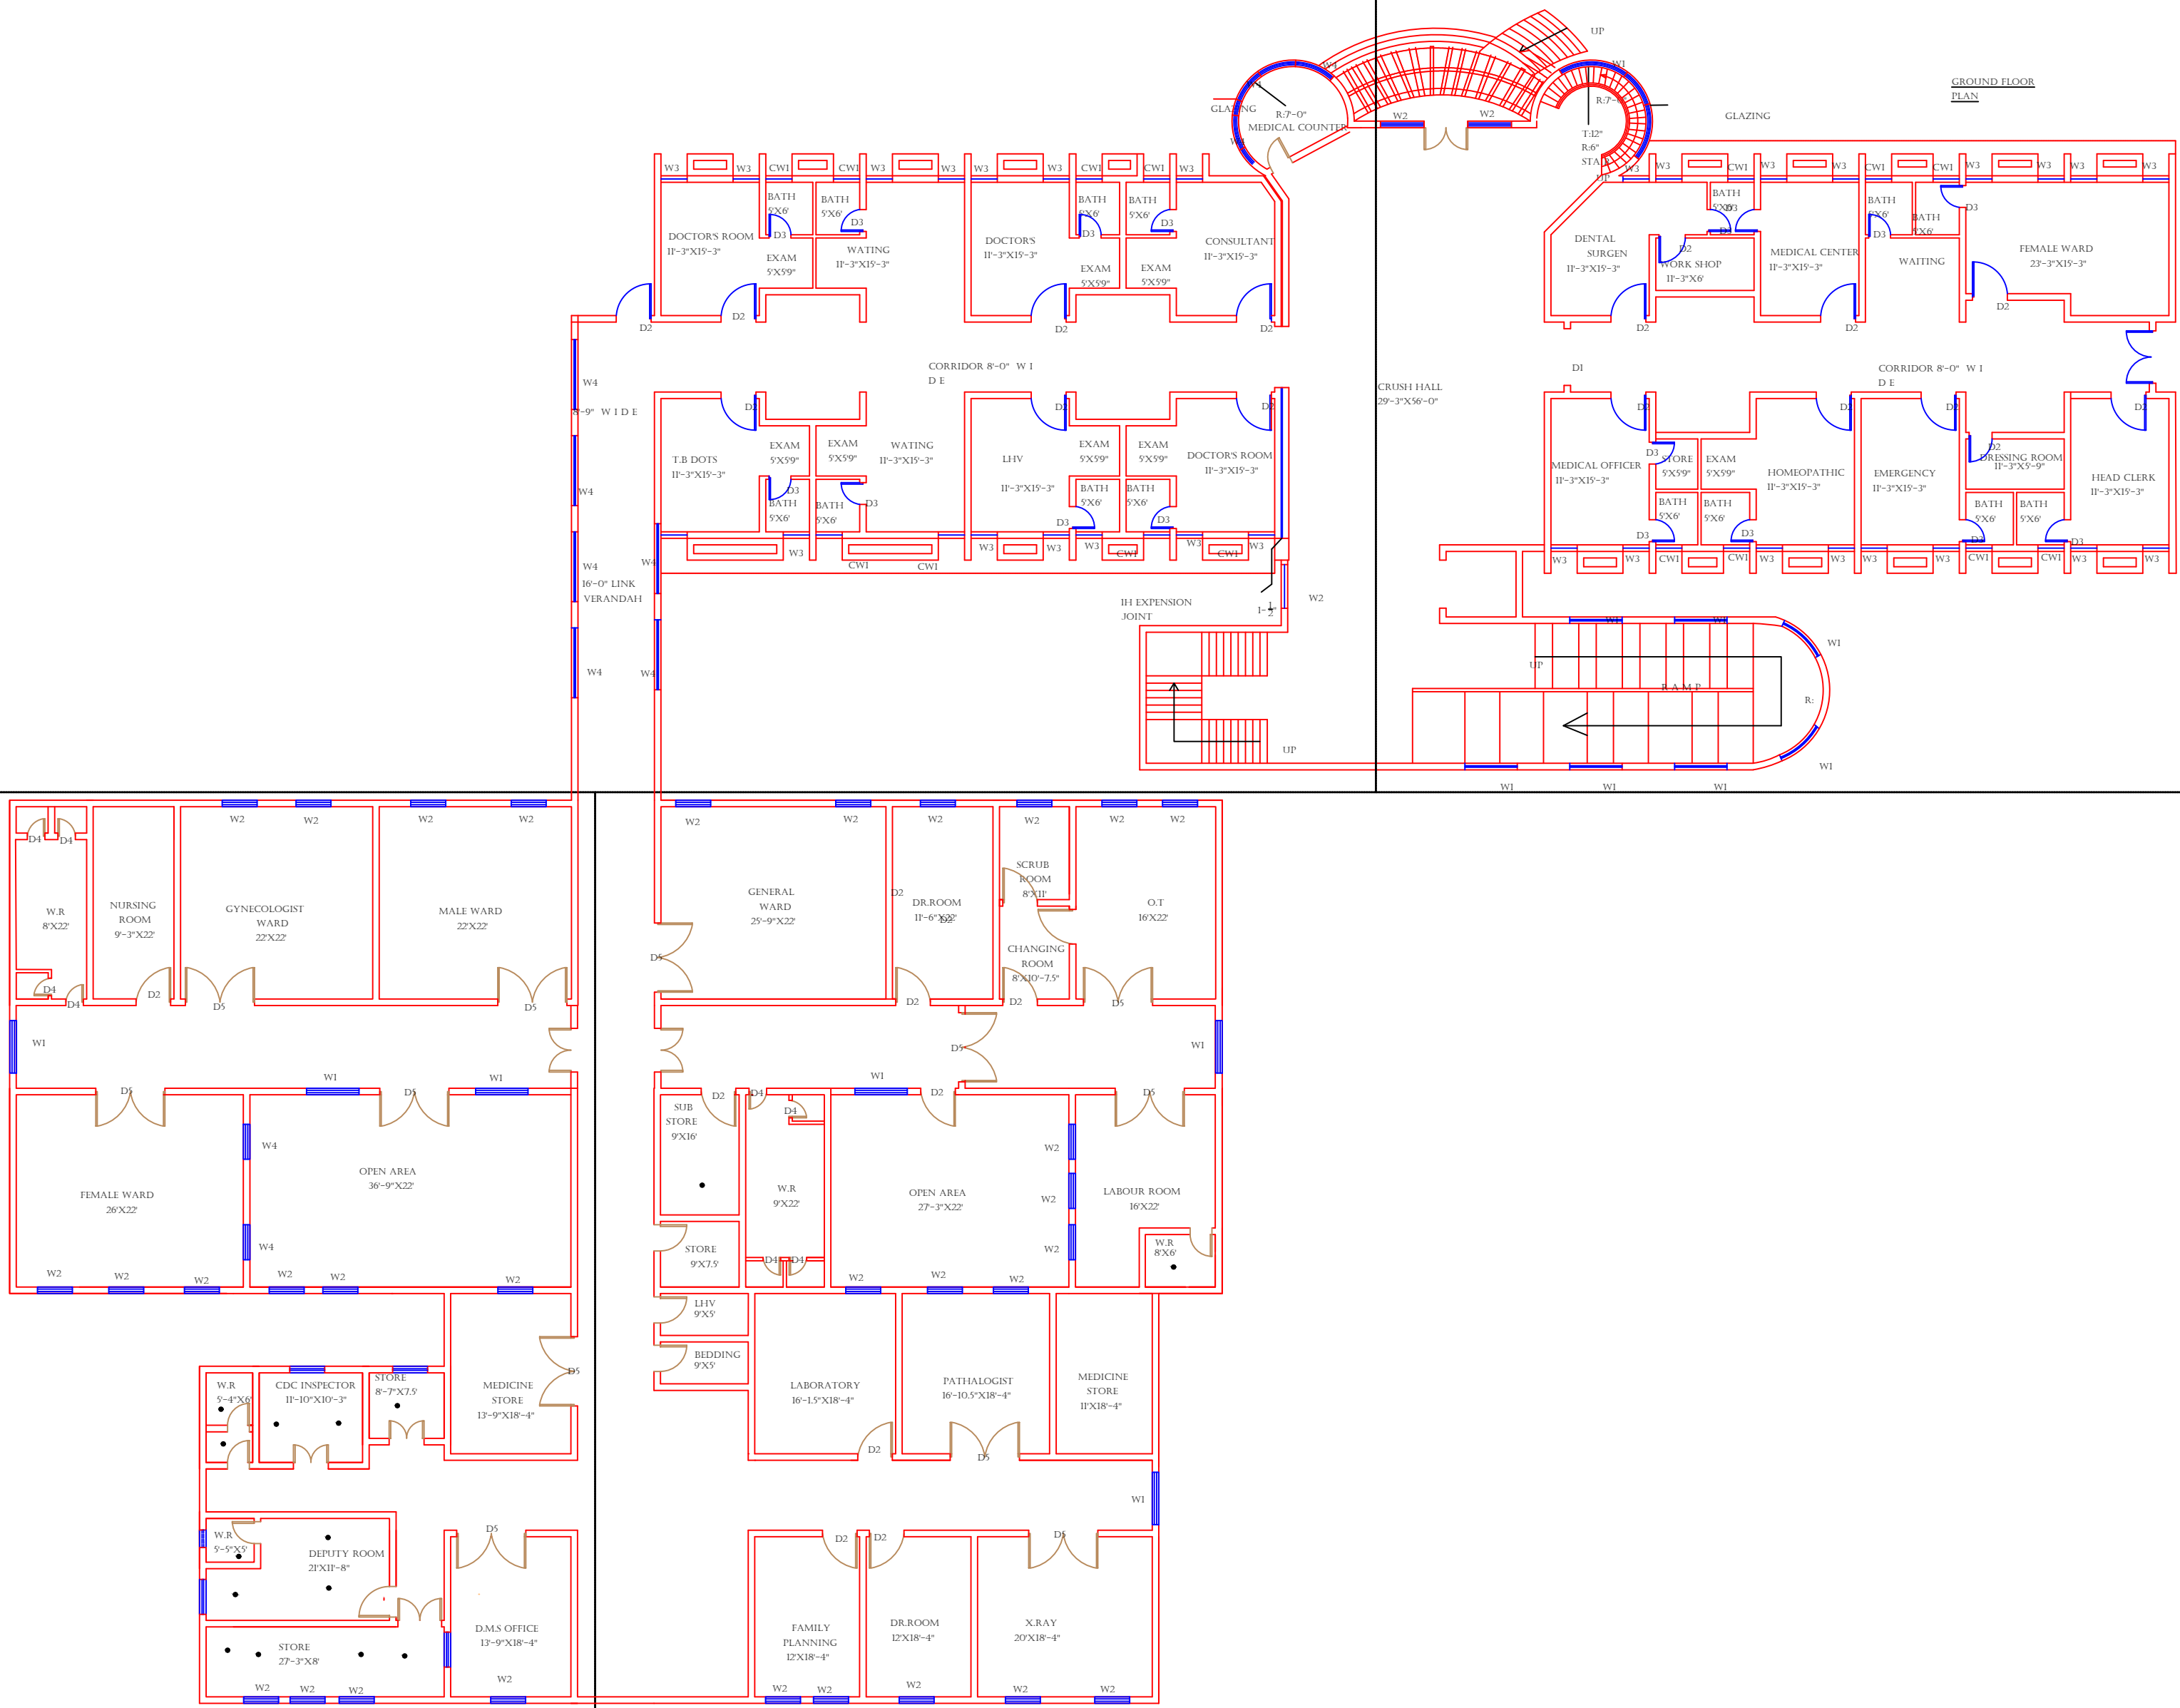

Legends:

RESIDENTIAL AREA	
ROAD	
WALL	
POWER LINE	
OHT	
TREE	
MANHOLE	
TUBE WELL	
LIGHT POLE	
LAWNS	
EARTHEN AREAS	
ASPHALTS ROADS	
TOUGH PAVERS	
P.C.C /PLINTH PROTECTION	
BOUNDARY WALL	
TAP	
HAND PUMP	
BRICK PAVERS	
AIR CONDITIONER	
TUBE LIGHT	
FAN	
ROOF LIGHT	
BULB	

AREA	
AREA WITHIN BOUNDARY WALL	32248413.6913 SFT
AREA OF CLINICAL BLOCK	18965778.5977 SFT
PLINTH AREA OF BLOCK	13470334.8618 SFT

OPENING SCHEDULE OF DOORS AND WINDOWS					
DOORS	WIDTH	HEIGHT	WINDOWS	WIDTH	HEIGHT
D1	5'-0"	7'-0"	W1	6'-0"	6'-0"
D2	3'-6"	7'-0"	W2	4'-0"	4'-0"
D3	2'-0"	7'-0"	W3	3'-0"	5'-0"
D4	8'-0"	7'-0"	W4	2'-0"	2'-0"
D5			W5		
D6			W6		
D7			W7		
D8			V1		
D9			V2		

Client:



**GOVERNMENT OF THE PUNJAB
PRIMARY & SECONDARY
HEALTHCARE DEPARTMENT**

Project:

**CAD MAPPING OF TEHSIL
HEAD QUARTER HOSPITALS,
PUNJAB**

Consultant:



SKAFS CONSULTANT (Pvt.) Limited
ENGINEERING AND ENVIRONMENT CONSULTANT

Drawing Title:

**THQ KOTMOMIN
HOSPITAL MAIN BUILDING
CLINICAL BLOCK PLAN**

Authorized By: SKAFS	Reviewed By Co-Team Leader	Scale: 1:400
Prepared By: CAD TEAMS	Date: FEB, 2017	
Drawing No. SKAFS/KOTMOMIN /08		

CLINICAL BLOCK OF THQ HOSPITAL KOT MOMIN

GROUND FLOOR (PART 1)

Legends:

RESIDENTIAL AREA	
ROAD	
WALL	
POWER LINE	
OHT	
TREE	
MANHOLE	
TUBE WELL	
LIGHT POLE	
LAWNS	
EARTHEN AREAS	
ASPHALTS ROADS	
TOUGH PAVERS	
P.C.C /PLINTH PROTECTION	
BOUNDARY WALL	
TAP	
HAND PUMP	
BRICK PAVERS	
AIR CONDITIONER	
TUBE LIGHT	
FAN	
ROOF LIGHT	
BULB	

AREA	
AREA WITHIN BOUNDARY WALL	32248413.6913 SFT
AREA OF CLINICAL BLOCK	18965778.5977 SFT
PLINTH AREA OF BLOCK	13470334.8618 SFT

OPENING SCHEDULE OF DOORS AND WINDOWS					
DOORS	WIDTH	HEIGHT	WINDOWS	WIDTH	HEIGHT
D1	5'-0"	7'-0"	W1	6'-0"	6'-0"
D2	3'-6"	7'-0"	W2	4'-0"	4'-0"
D3	2'-0"	7'-0"	W3	3'-0"	5'-0"
D4	8'-0"	7'-0"	W4	2'-0"	2'-0"
D5			W5		
D6			W6		
D7			W7		
D8			V1		
D9			V2		

Client:



GOVERNMENT OF THE PUNJAB
PRIMARY & SECONDARY
HEALTHCARE DEPARTMENT

Project:

CAD MAPPING OF TEHSIL
HEAD QUARTER HOSPITALS,
PUNJAB

Consultant:



SKAFS CONSULTANT (Pvt.) Limited
ENGINEERING AND ENVIRONMENT CONSULTANT

Drawing Title:

THQ KOTMOMIN
HOSPITAL CLINICAL BLOCK
PART 1

Authorized By:
SKAFS

Reviewed By
Co-Team Leader


Scale:

Prepared By:
CAD TEAMS

Date:
FEB, 2017


Drawing No.

SKAFS/KOTMOMIN /09

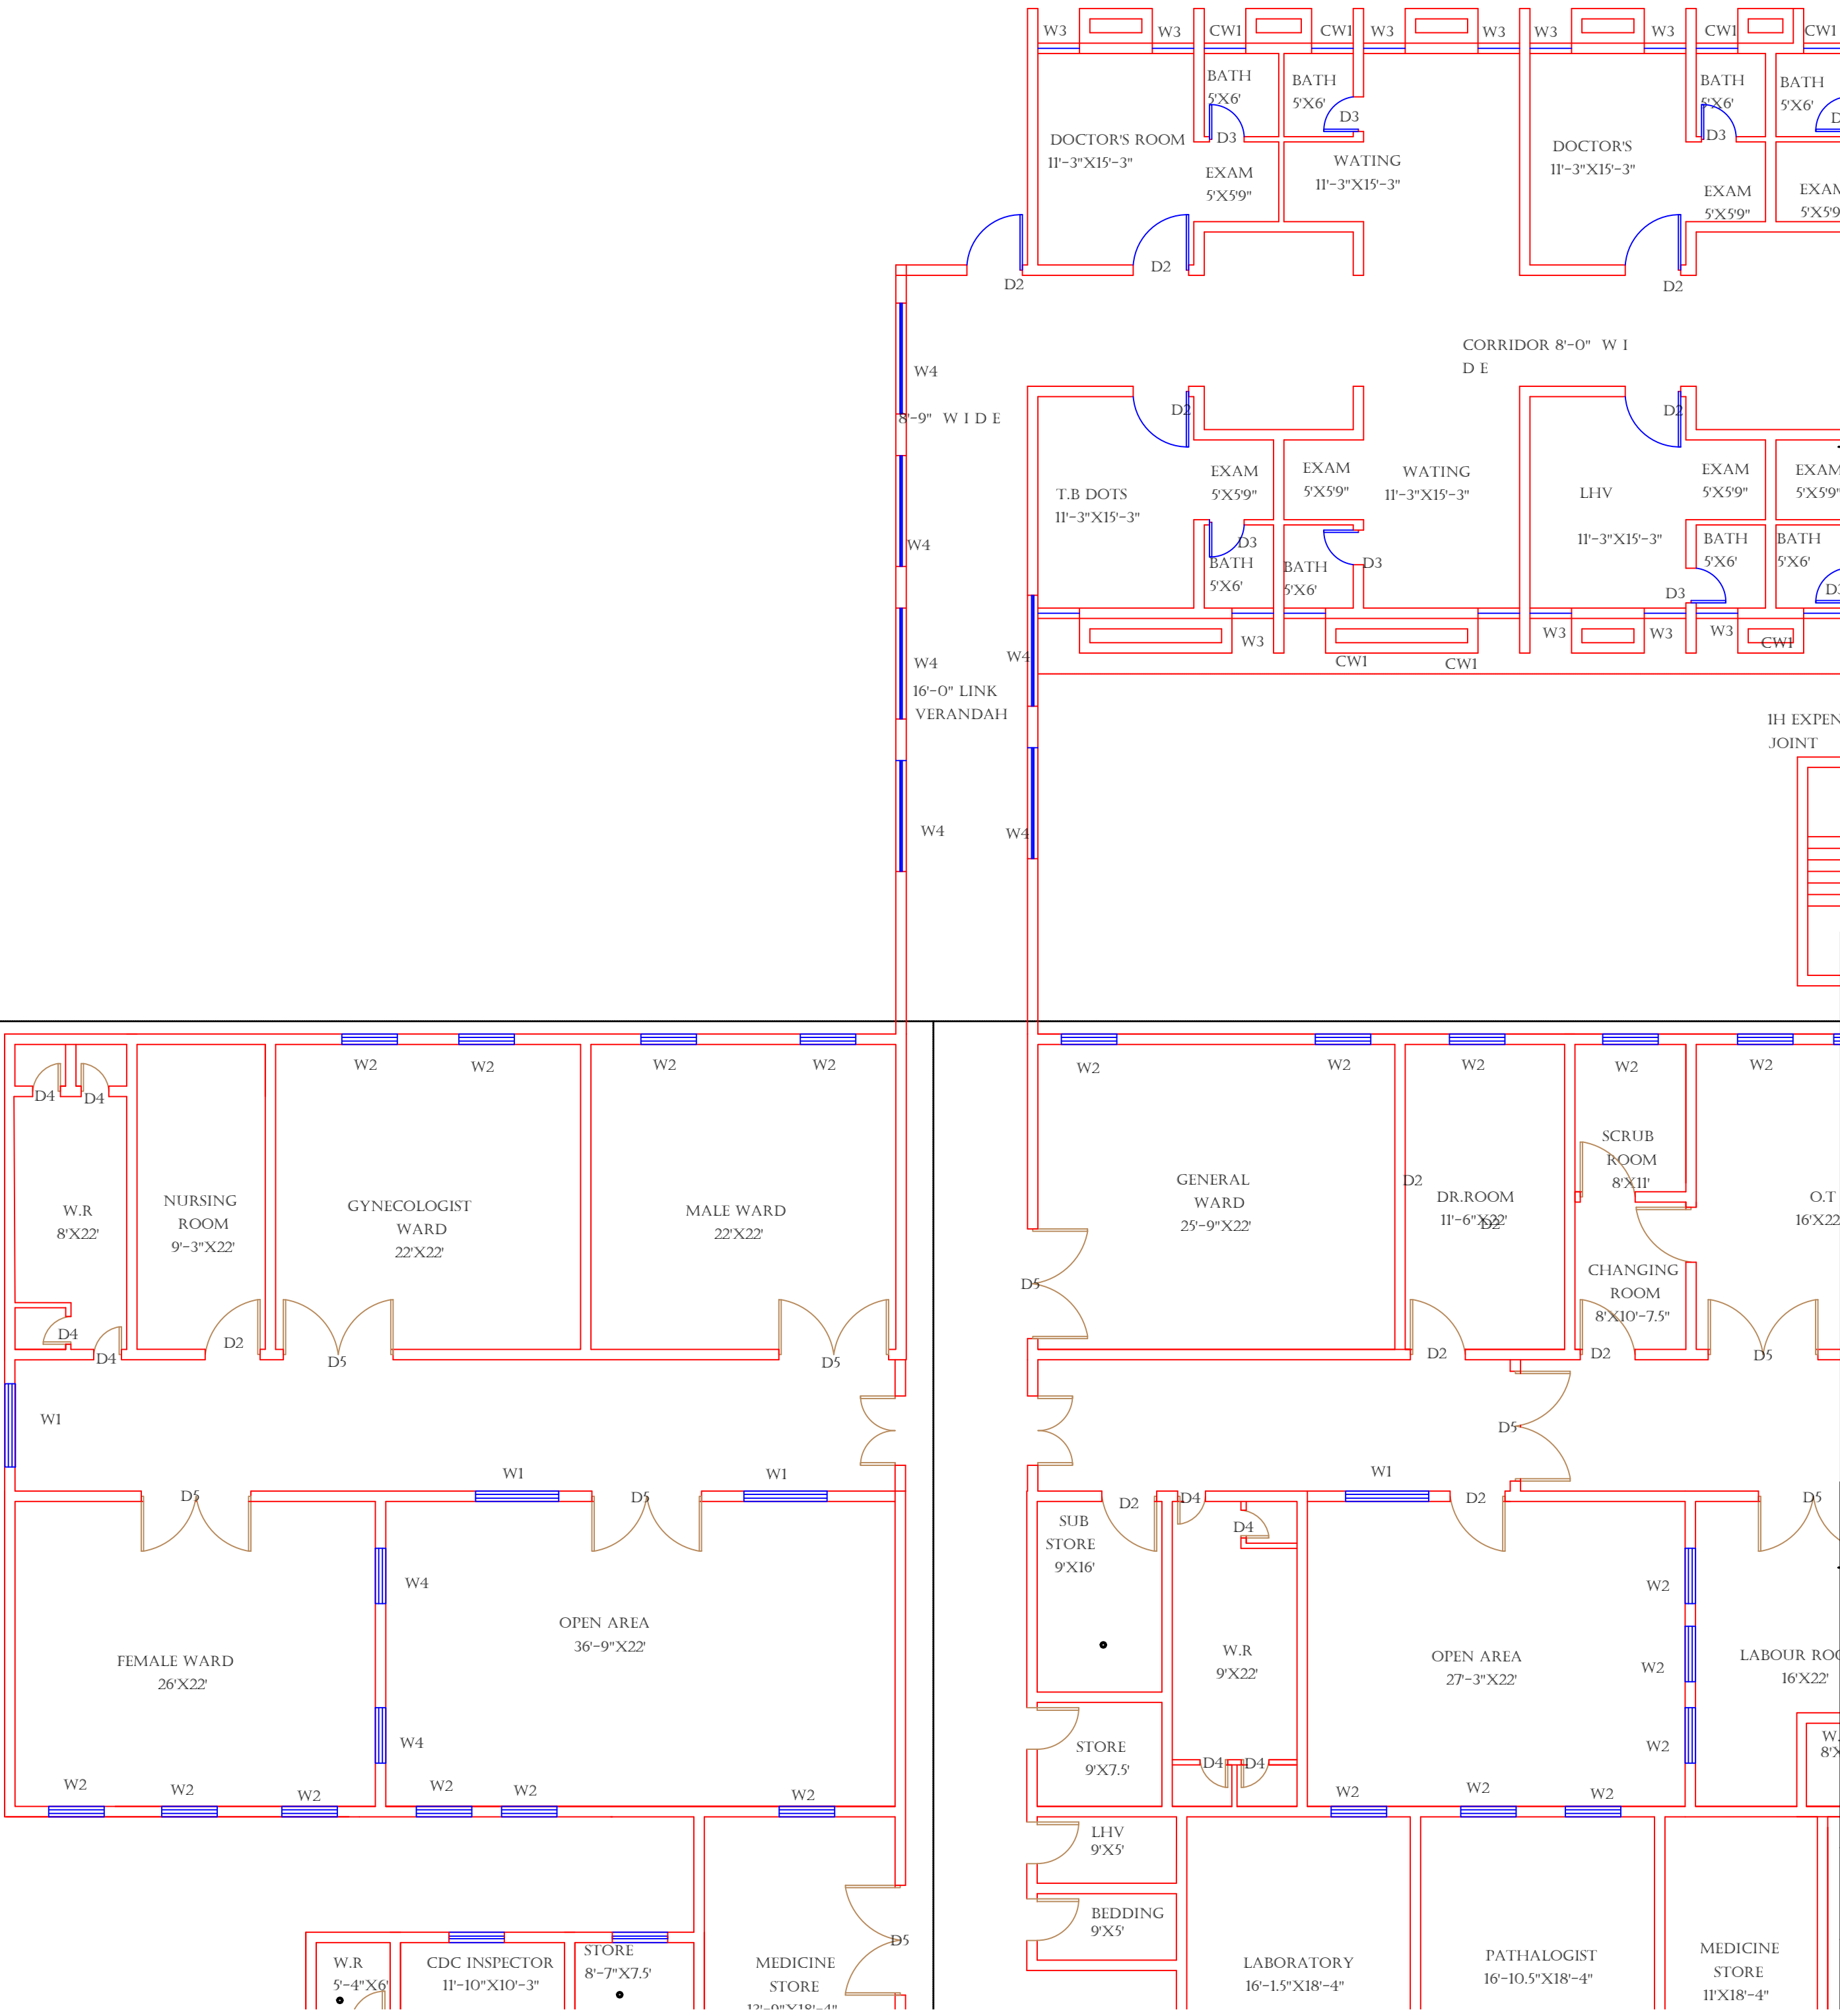


CLINICAL BLOCK OF THQ HOSPITAL KOT MOMIN

GROUND FLOOR (PART 2)

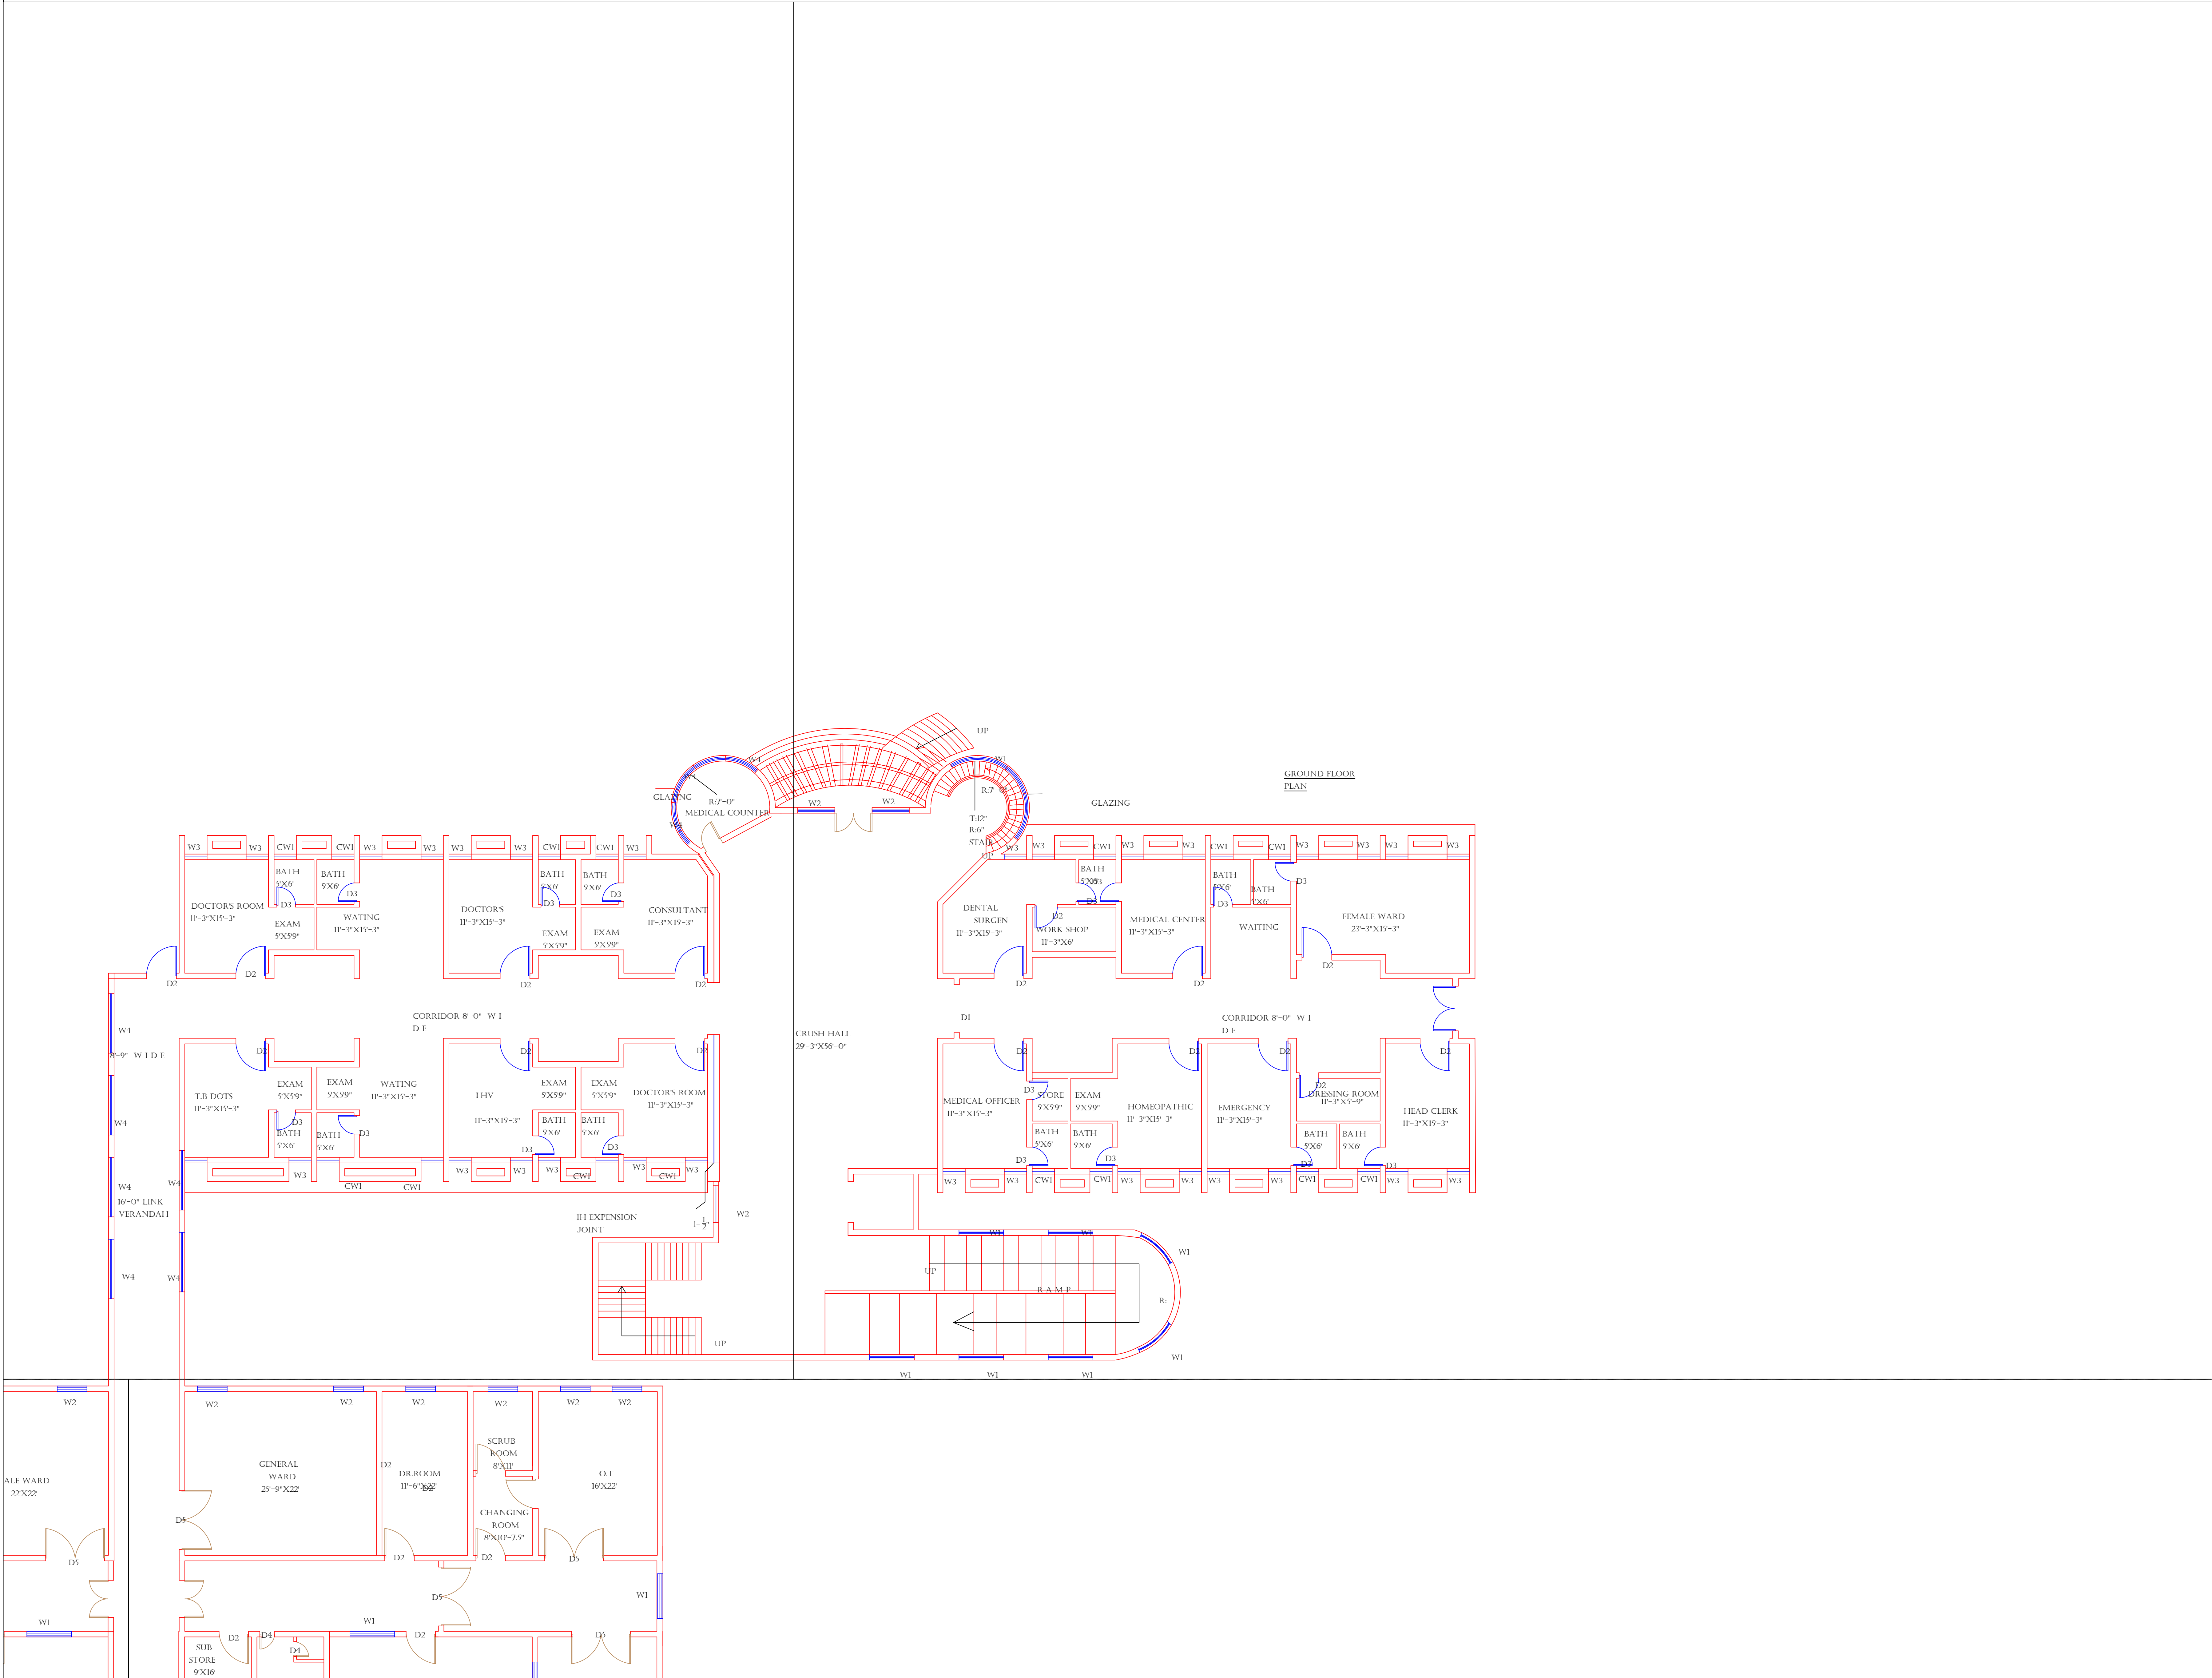

CLINICAL BLOCK OF THQ HOSPITAL KOT MOMIN

GROUND FLOOR (PART 3)

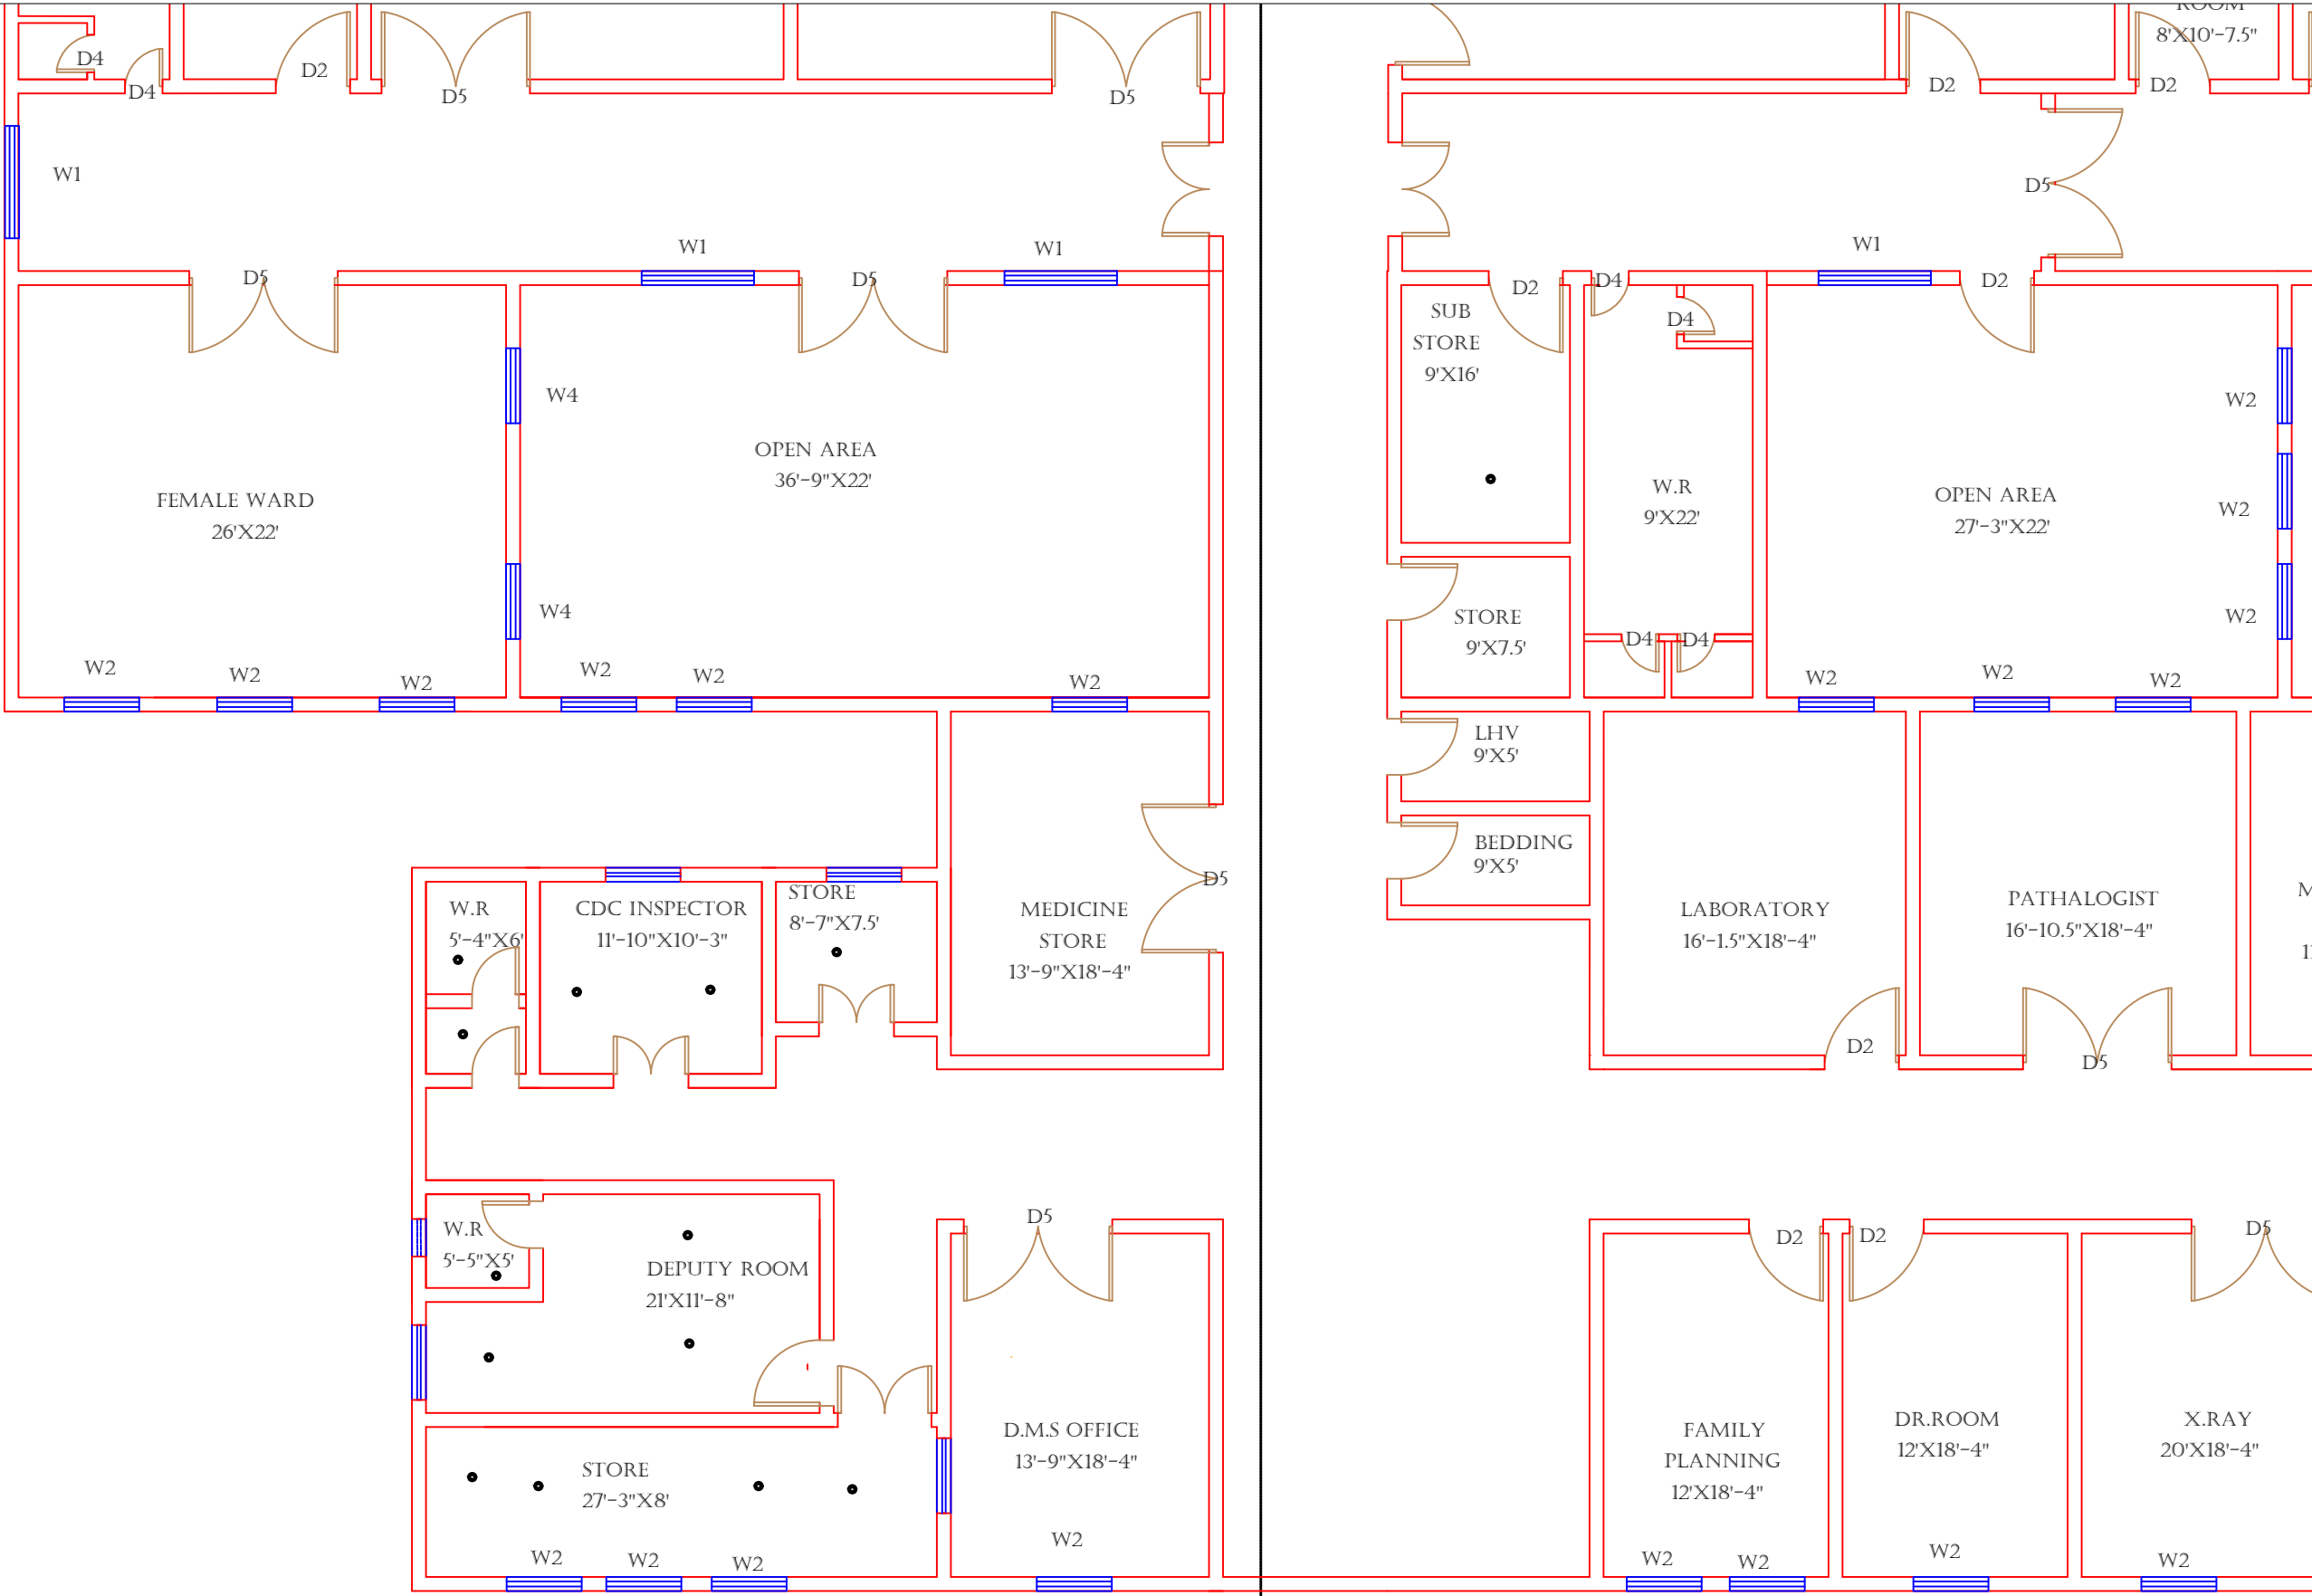

Legends:	
RESIDENTIAL AREA	
ROAD	
WALL	
POWER LINE	
OHT	
TREE	
MANHOLE	
TUBE WELL	
LIGHT POLE	
LAWNS	
EARTHEN AREAS	
ASPHALTS ROADS	
TOUGH PAVERS	
P.C.C /PLINTH PROTECTION	
BOUNDARY WALL	
TAP	
HAND PUMP	
BRICK PAVERS	
AIR CONDITIONER	
TUBE LIGHT	
FAN	
ROOF LIGHT	
BULB	

AREA	
AREA WITHIN BOUNDARY WALL	32248413.6913 SFT
AREA OF CLINICAL BLOCK	18965778.5977 SFT
PLINTH AREA OF BLOCK	13470334.8618 SFT

OPENING SCHEDULE OF DOORS AND WINDOWS					
DOORS	WIDTH	HEIGHT	WINDOWS	WIDTH	HEIGHT
D1	5'-0"	7'-0"	W1	6'-0"	6'-0"
D2	3'-6"	7'-0"	W2	4'-0"	4'-0"
D3	2'-0"	7'-0"	W3	3'-0"	5'-0"
D4	8'-0"	7'-0"	W4	2'-0"	2'-0"
D5			W5		
D6			W6		
D7			W7		
D8			V1		
D9			V2		

Client:



GOVERNMENT OF THE PUNJAB
PRIMARY & SECONDARY
HEALTHCARE DEPARTMENT

Project:

CAD MAPPING OF TEHSIL
HEAD QUARTER HOSPITALS,
PUNJAB

Consultant:



SKAFS CONSULTANT (Pvt.) Limited
ENGINEERING AND ENVIRONMENT CONSULTANT

Drawing Title:

THQ KOTMOMIN
HOSPITAL CLINICAL BLOCK
PART 3


Authorized By: SKAFS	Reviewed By Co-Team Leader	Scale:
Prepared By: CAD TEAMS	Date: FEB, 2017	

Drawing No.

SKAFS/KOTMOMIN /11

CLINICAL BLOCK OF THQ HOSPITAL KOT MOMIN

GROUND FLOOR (PART 4)

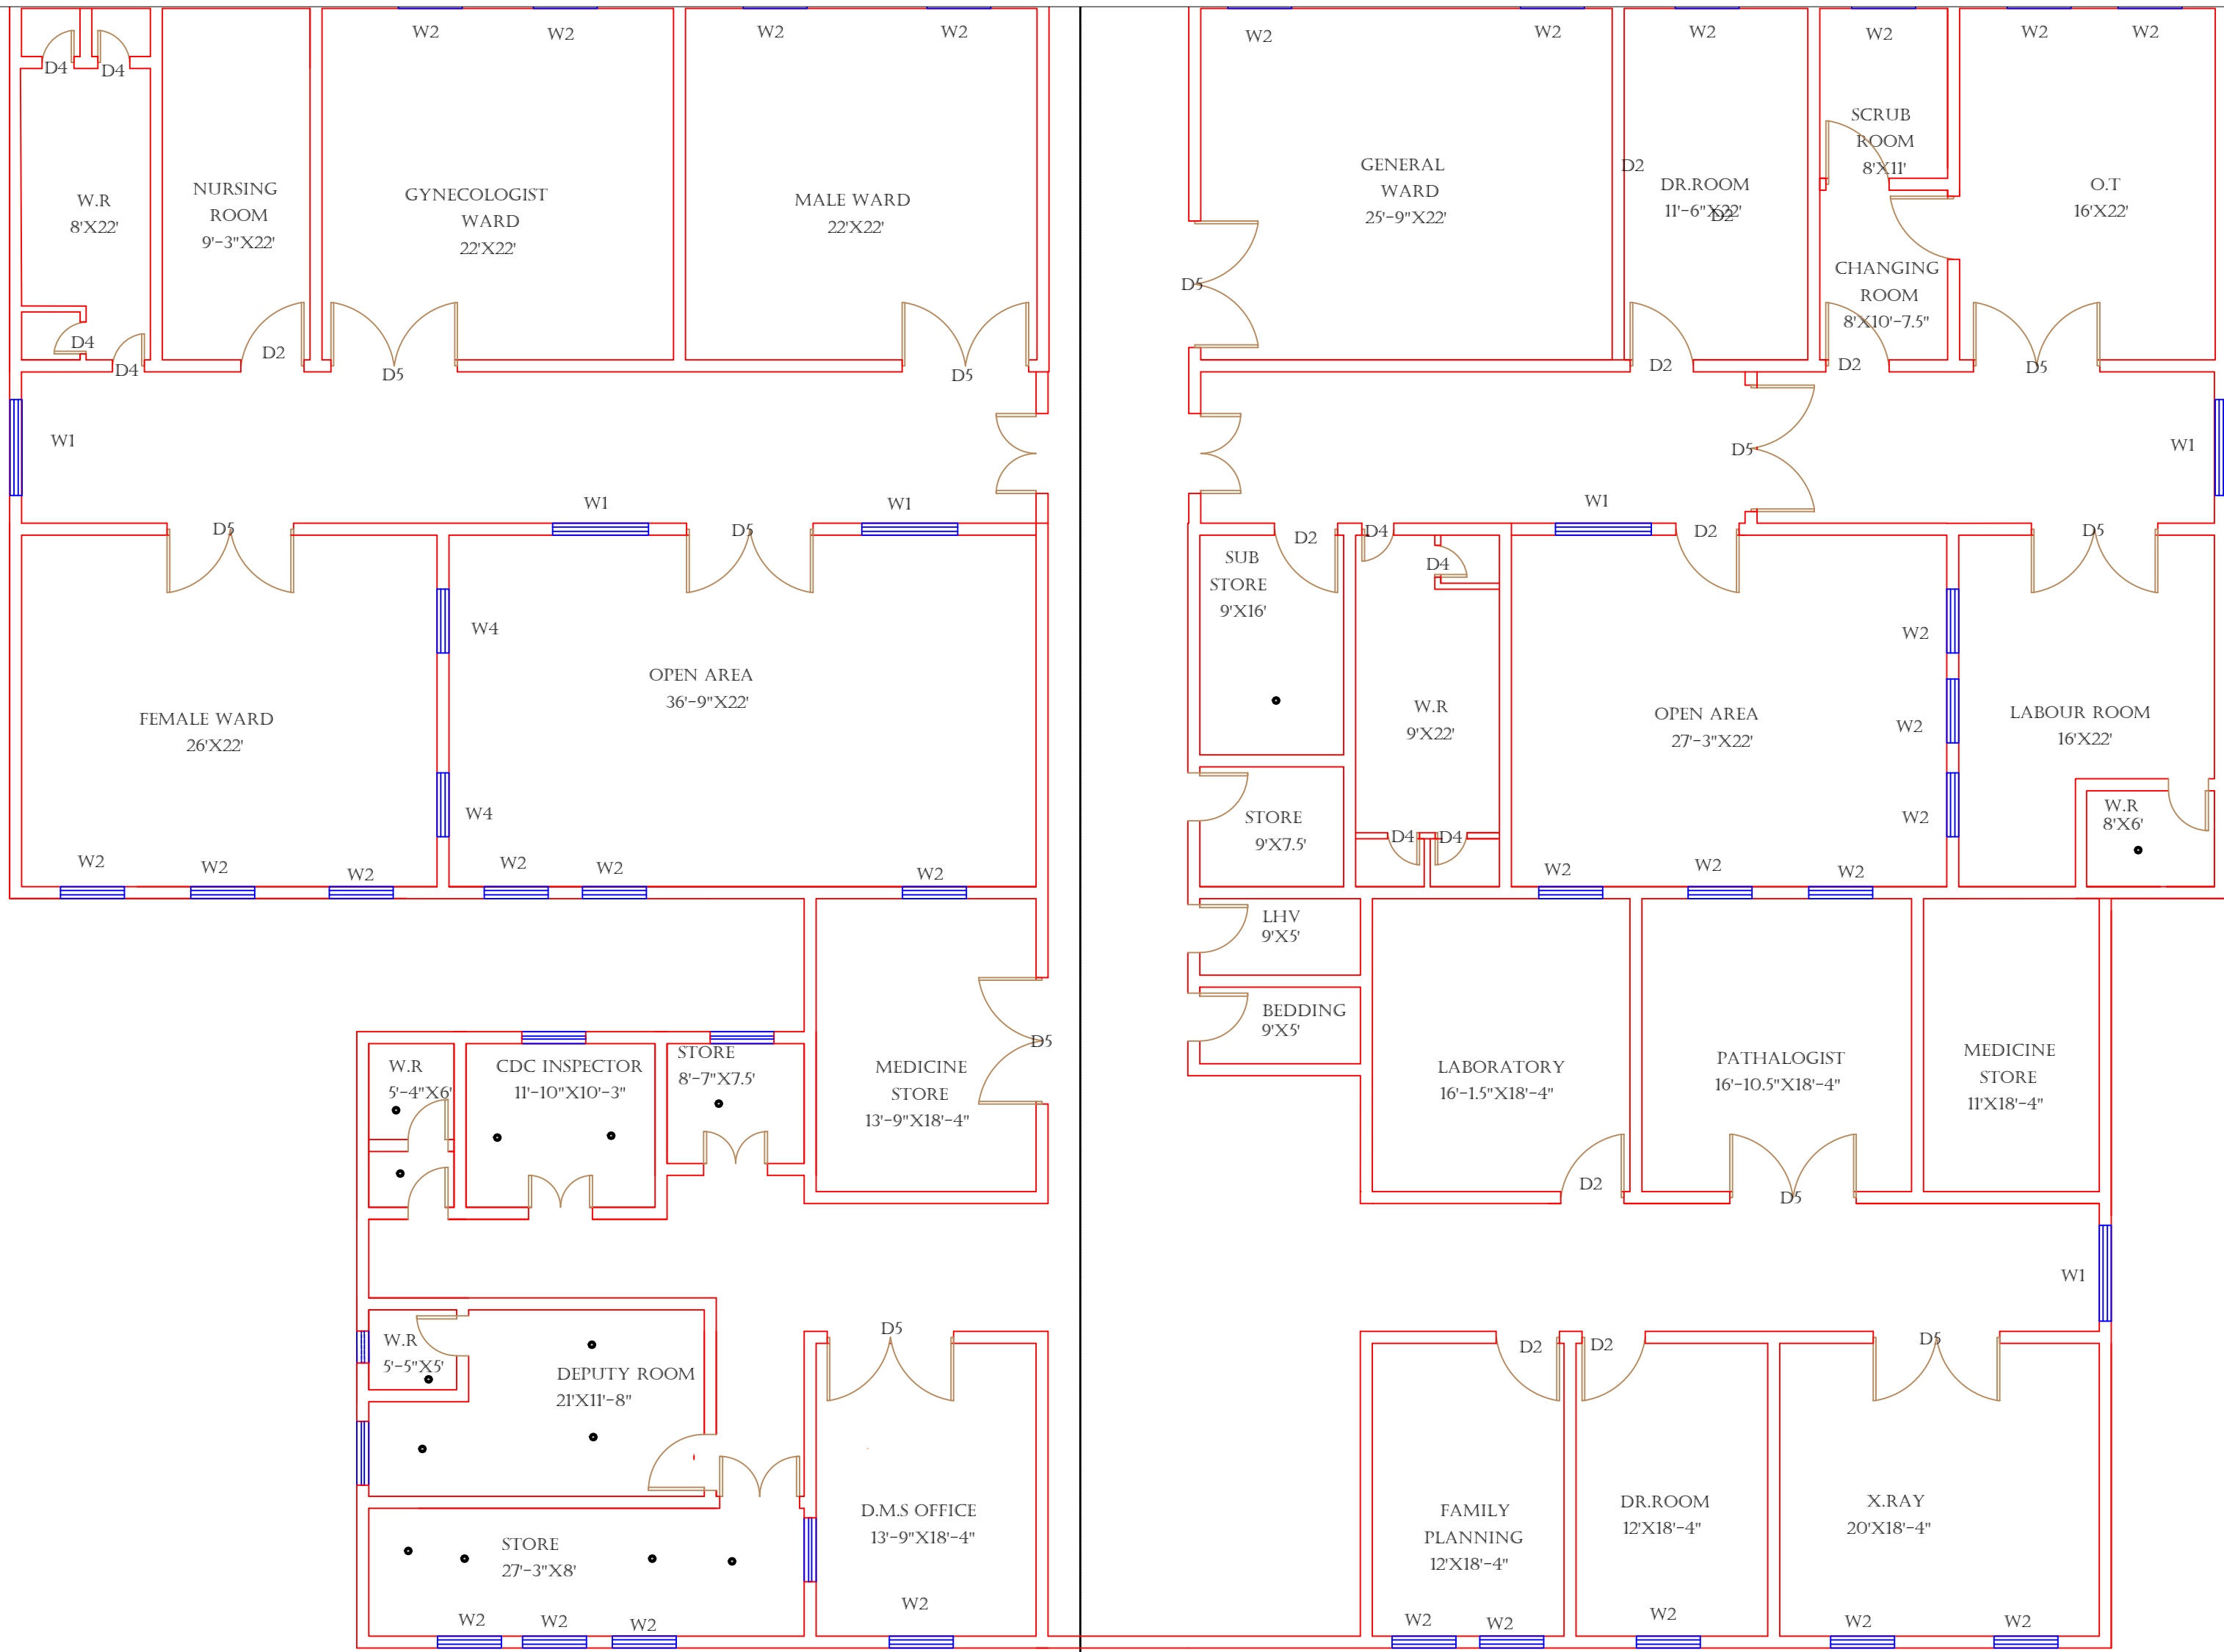

Legends:	
RESIDENTIAL AREA	
ROAD	
WALL	
POWER LINE	
OHT	
TREE	
MANHOLE	
TUBE WELL	
LIGHT POLE	
LAWNS	
EARTHEN AREAS	
ASPHALTS ROADS	
TOUGH PAVERS	
P.C.C /PLINTH PROTECTION	
BOUNDARY WALL	
TAP	
HAND PUMP	
BRICK PAVERS	
AIR CONDITIONER	
TUBE LIGHT	
FAN	
ROOF LIGHT	
BULB	

AREA	
AREA WITHIN BOUNDARY WALL	32248413.6913 SFT
AREA OF CLINICAL BLOCK	18965778.5977 SFT
PLINTH AREA OF BLOCK	13470334.8618 SFT

OPENING SCHEDULE OF DOORS AND WINDOWS					
DOORS	WIDTH	HEIGHT	WINDOWS	WIDTH	HEIGHT
D1	5'-0"	7'-0"	W1	6'-0"	6'-0"
D2	3'-6"	7'-0"	W2	4'-0"	4'-0"
D3	2'-0"	7'-0"	W3	3'-0"	5'-0"
D4	8'-0"	7'-0"	W4	2'-0"	2'-0"
D5			W5		
D6			W6		
D7			W7		
D8			V1		
D9			V2		

Client:



GOVERNMENT OF THE PUNJAB
PRIMARY & SECONDARY
HEALTHCARE DEPARTMENT

Project:

CAD MAPPING OF TEHSIL
HEAD QUARTER HOSPITALS,
PUNJAB

Consultant:



SKAFS CONSULTANT (Pvt.) Limited
ENGINEERING AND ENVIRONMENT CONSULTANT

Drawing Title:

THQ KOTMOMIN
HOSPITAL CLINICAL BLOCK
PART 4


Authorized By: SKAFS	Reviewed By Co-Team Leader	Scale:
-------------------------	-------------------------------	--------

Prepared By: CAD TEAMS	Date: FEB, 2017	
---------------------------	--------------------	--

Drawing No.	SKAFS/KOTMOMIN /12
-------------	--------------------

CLINICAL BLOCK OF THQ HOSPITAL KOT MOMIN

FIRST FLOOR (PART 1)

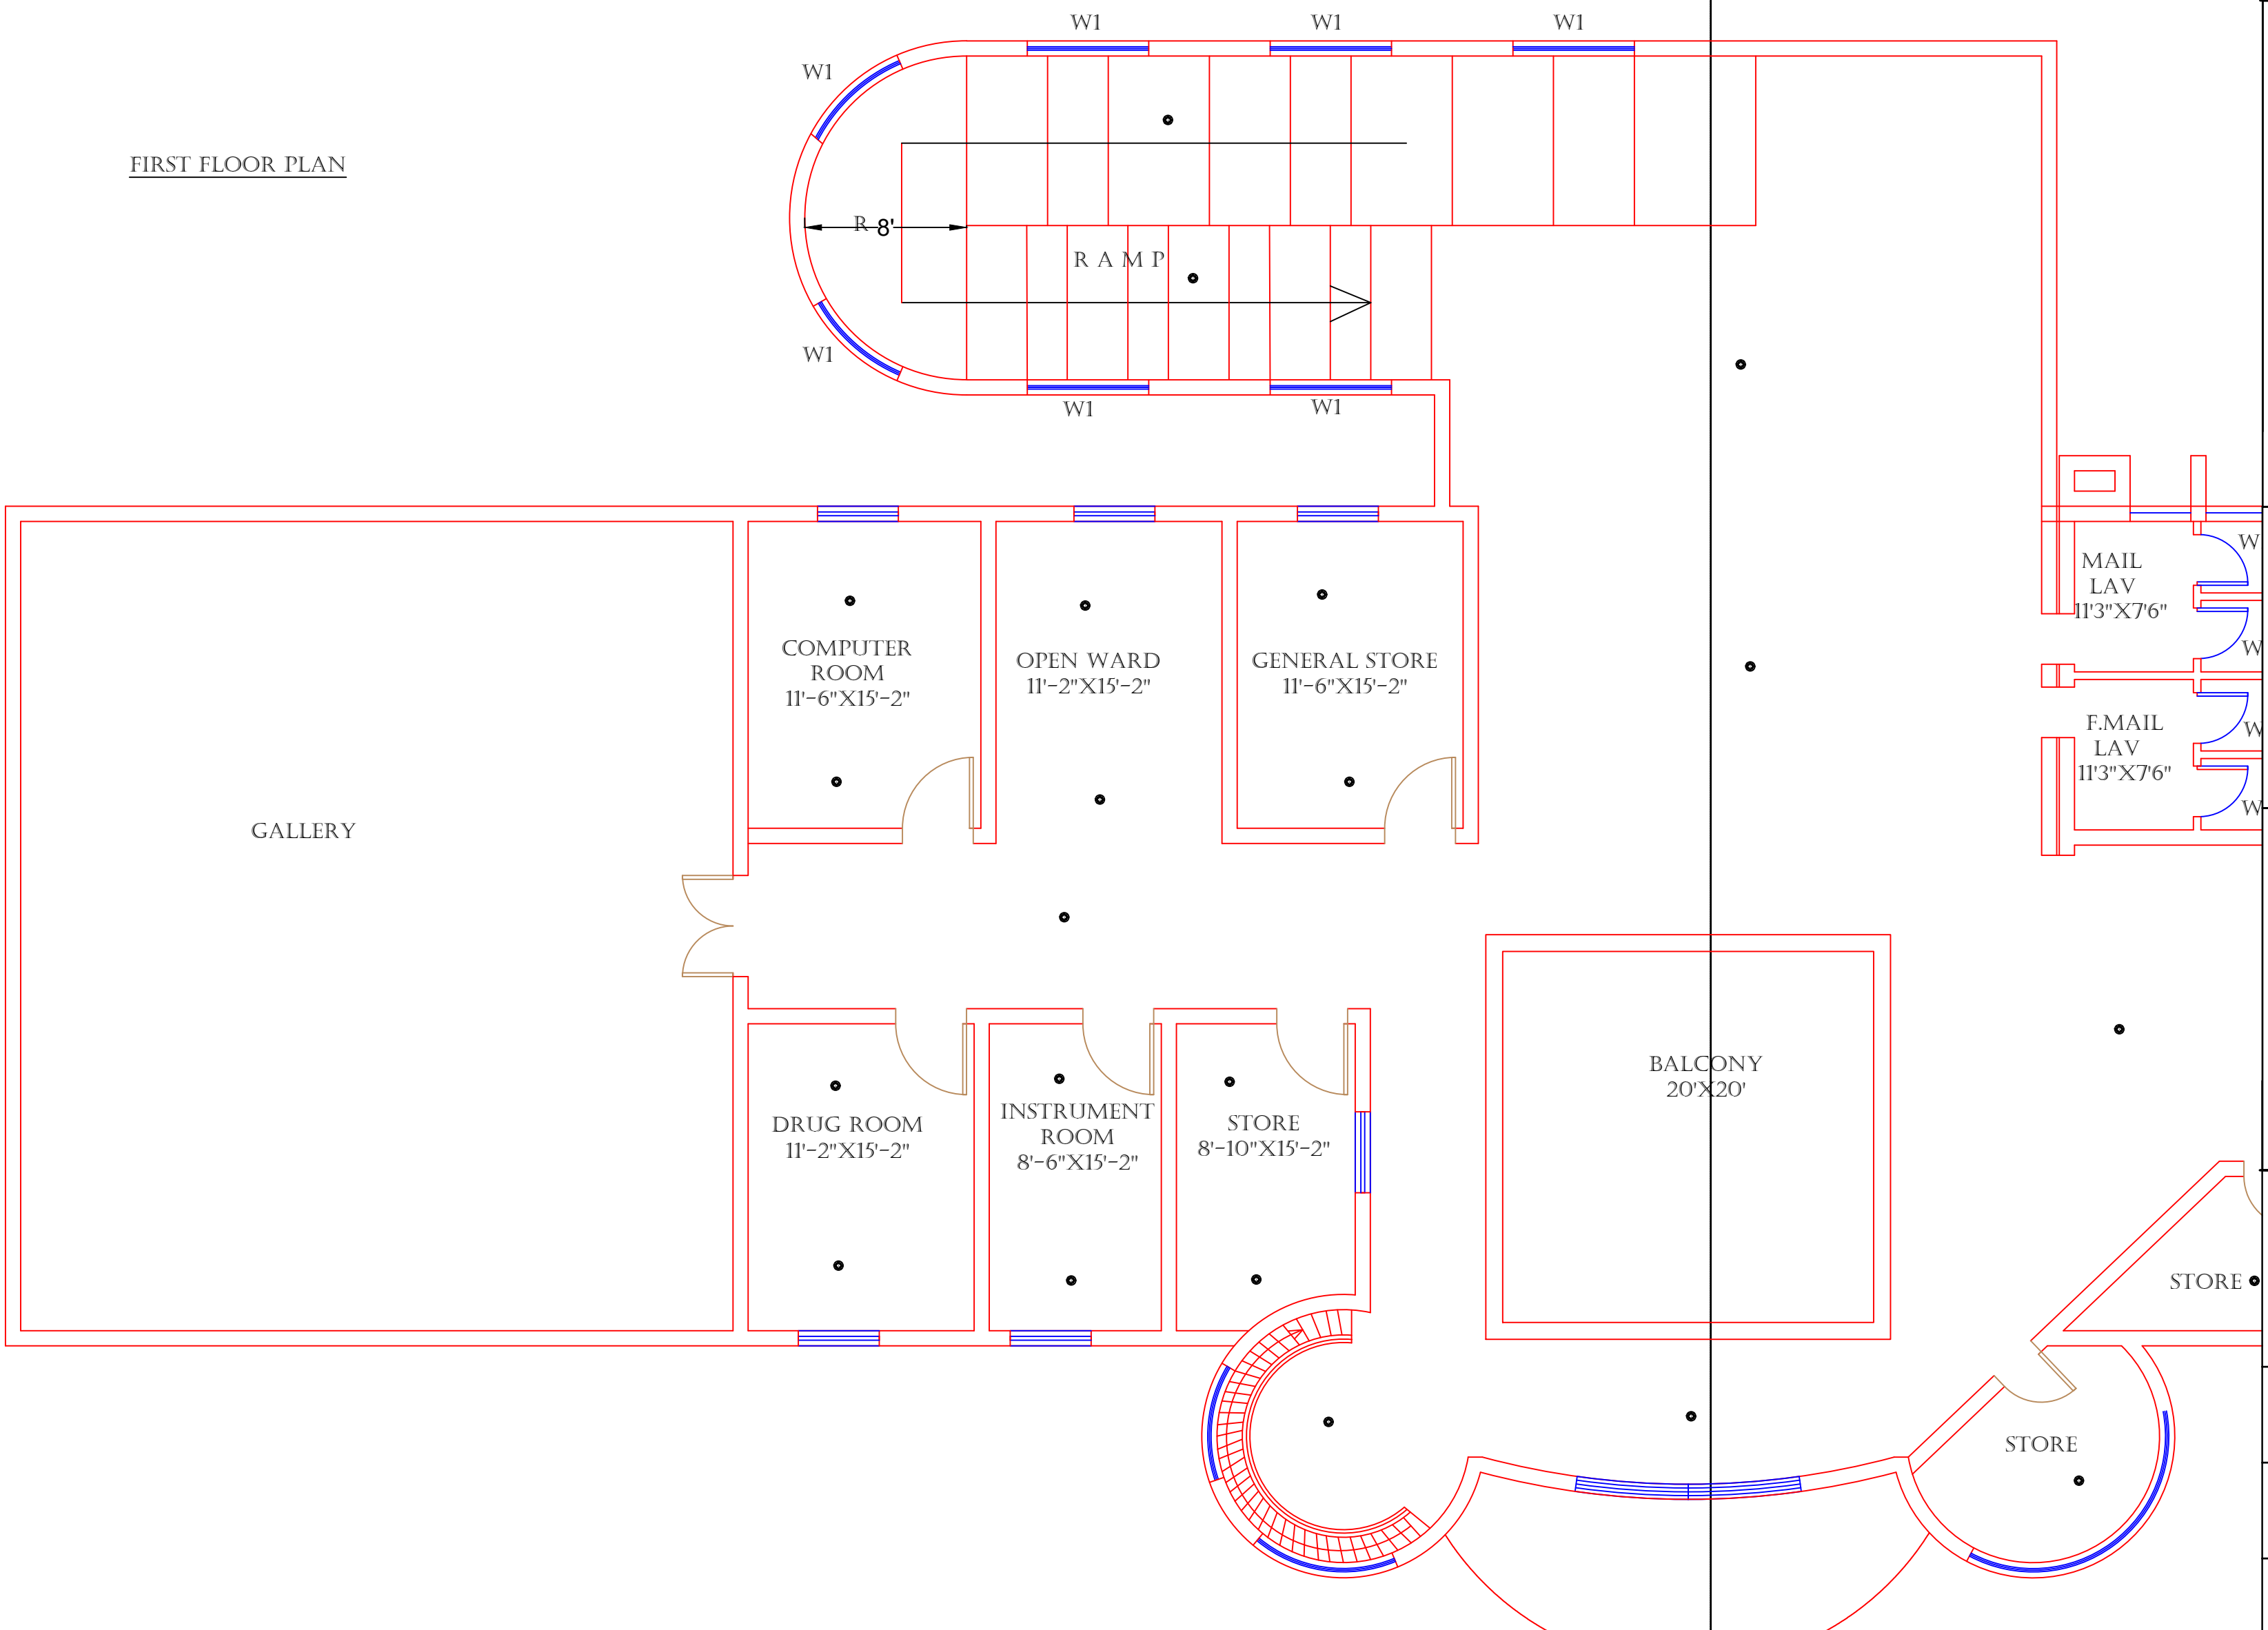

Legends:

RESIDENTIAL AREA	
ROAD	
WALL	
POWER LINE	
OHT	
TREE	
MANHOLE	
TUBE WELL	
LIGHT POLE	
LAWNS	
EARTHEN AREAS	
ASPHALTS ROADS	
TOUGH PAVERS	
P.C.C /PLINTH PROTECTION	
BOUNDARY WALL	
TAP	
HAND PUMP	
BRICK PAVERS	
AIR CONDITIONER	
TUBE LIGHT	
FAN	
ROOF LIGHT	
BULB	

AREA	
AREA WITHIN BOUNDARY WALL	32248413.6913 SFT
AREA OF CLINICAL BLOCK	18965778.5977 SFT
PLINTH AREA OF BLOCK	13470334.8618 SFT

OPENING SCHEDULE OF DOORS AND WINDOWS					
DOORS	WIDTH	HEIGHT	WINDOWS	WIDTH	HEIGHT
D1	5'-0"	7'-0"	W1	6'-0"	6'-0"
D2	3'-6"	7'-0"	W2	4'-0"	4'-0"
D3	2'-0"	7'-0"	W3	3'-0"	5'-0"
D4	8'-0"	7'-0"	W4	2'-0"	2'-0"
D5			W5		
D6			W6		
D7			W7		
D8			V1		
D9			V2		

Client:



GOVERNMENT OF THE PUNJAB
PRIMARY & SECONDARY
HEALTHCARE DEPARTMENT

Project:

CAD MAPPING OF TEHSIL
HEAD QUARTER HOSPITALS,
PUNJAB

Consultant:



SKAFS CONSULTANT (Pvt.) Limited
ENGINEERING AND ENVIRONMENT CONSULTANT

Drawing Title:

THQ KOTMOMIN
HOSPITAL CLINICAL BLOCK
PART 4


Authorized By: SKAFS	Reviewed By Co-Team Leader	Scale:
Prepared By: CAD TEAMS	Date: FEB, 2017	

Drawing No.

SKAFS/KOTMOMIN /13

CLINICAL BLOCK OF THQ HOSPITAL KOT MOMIN

FIRST FLOOR (PART 2)

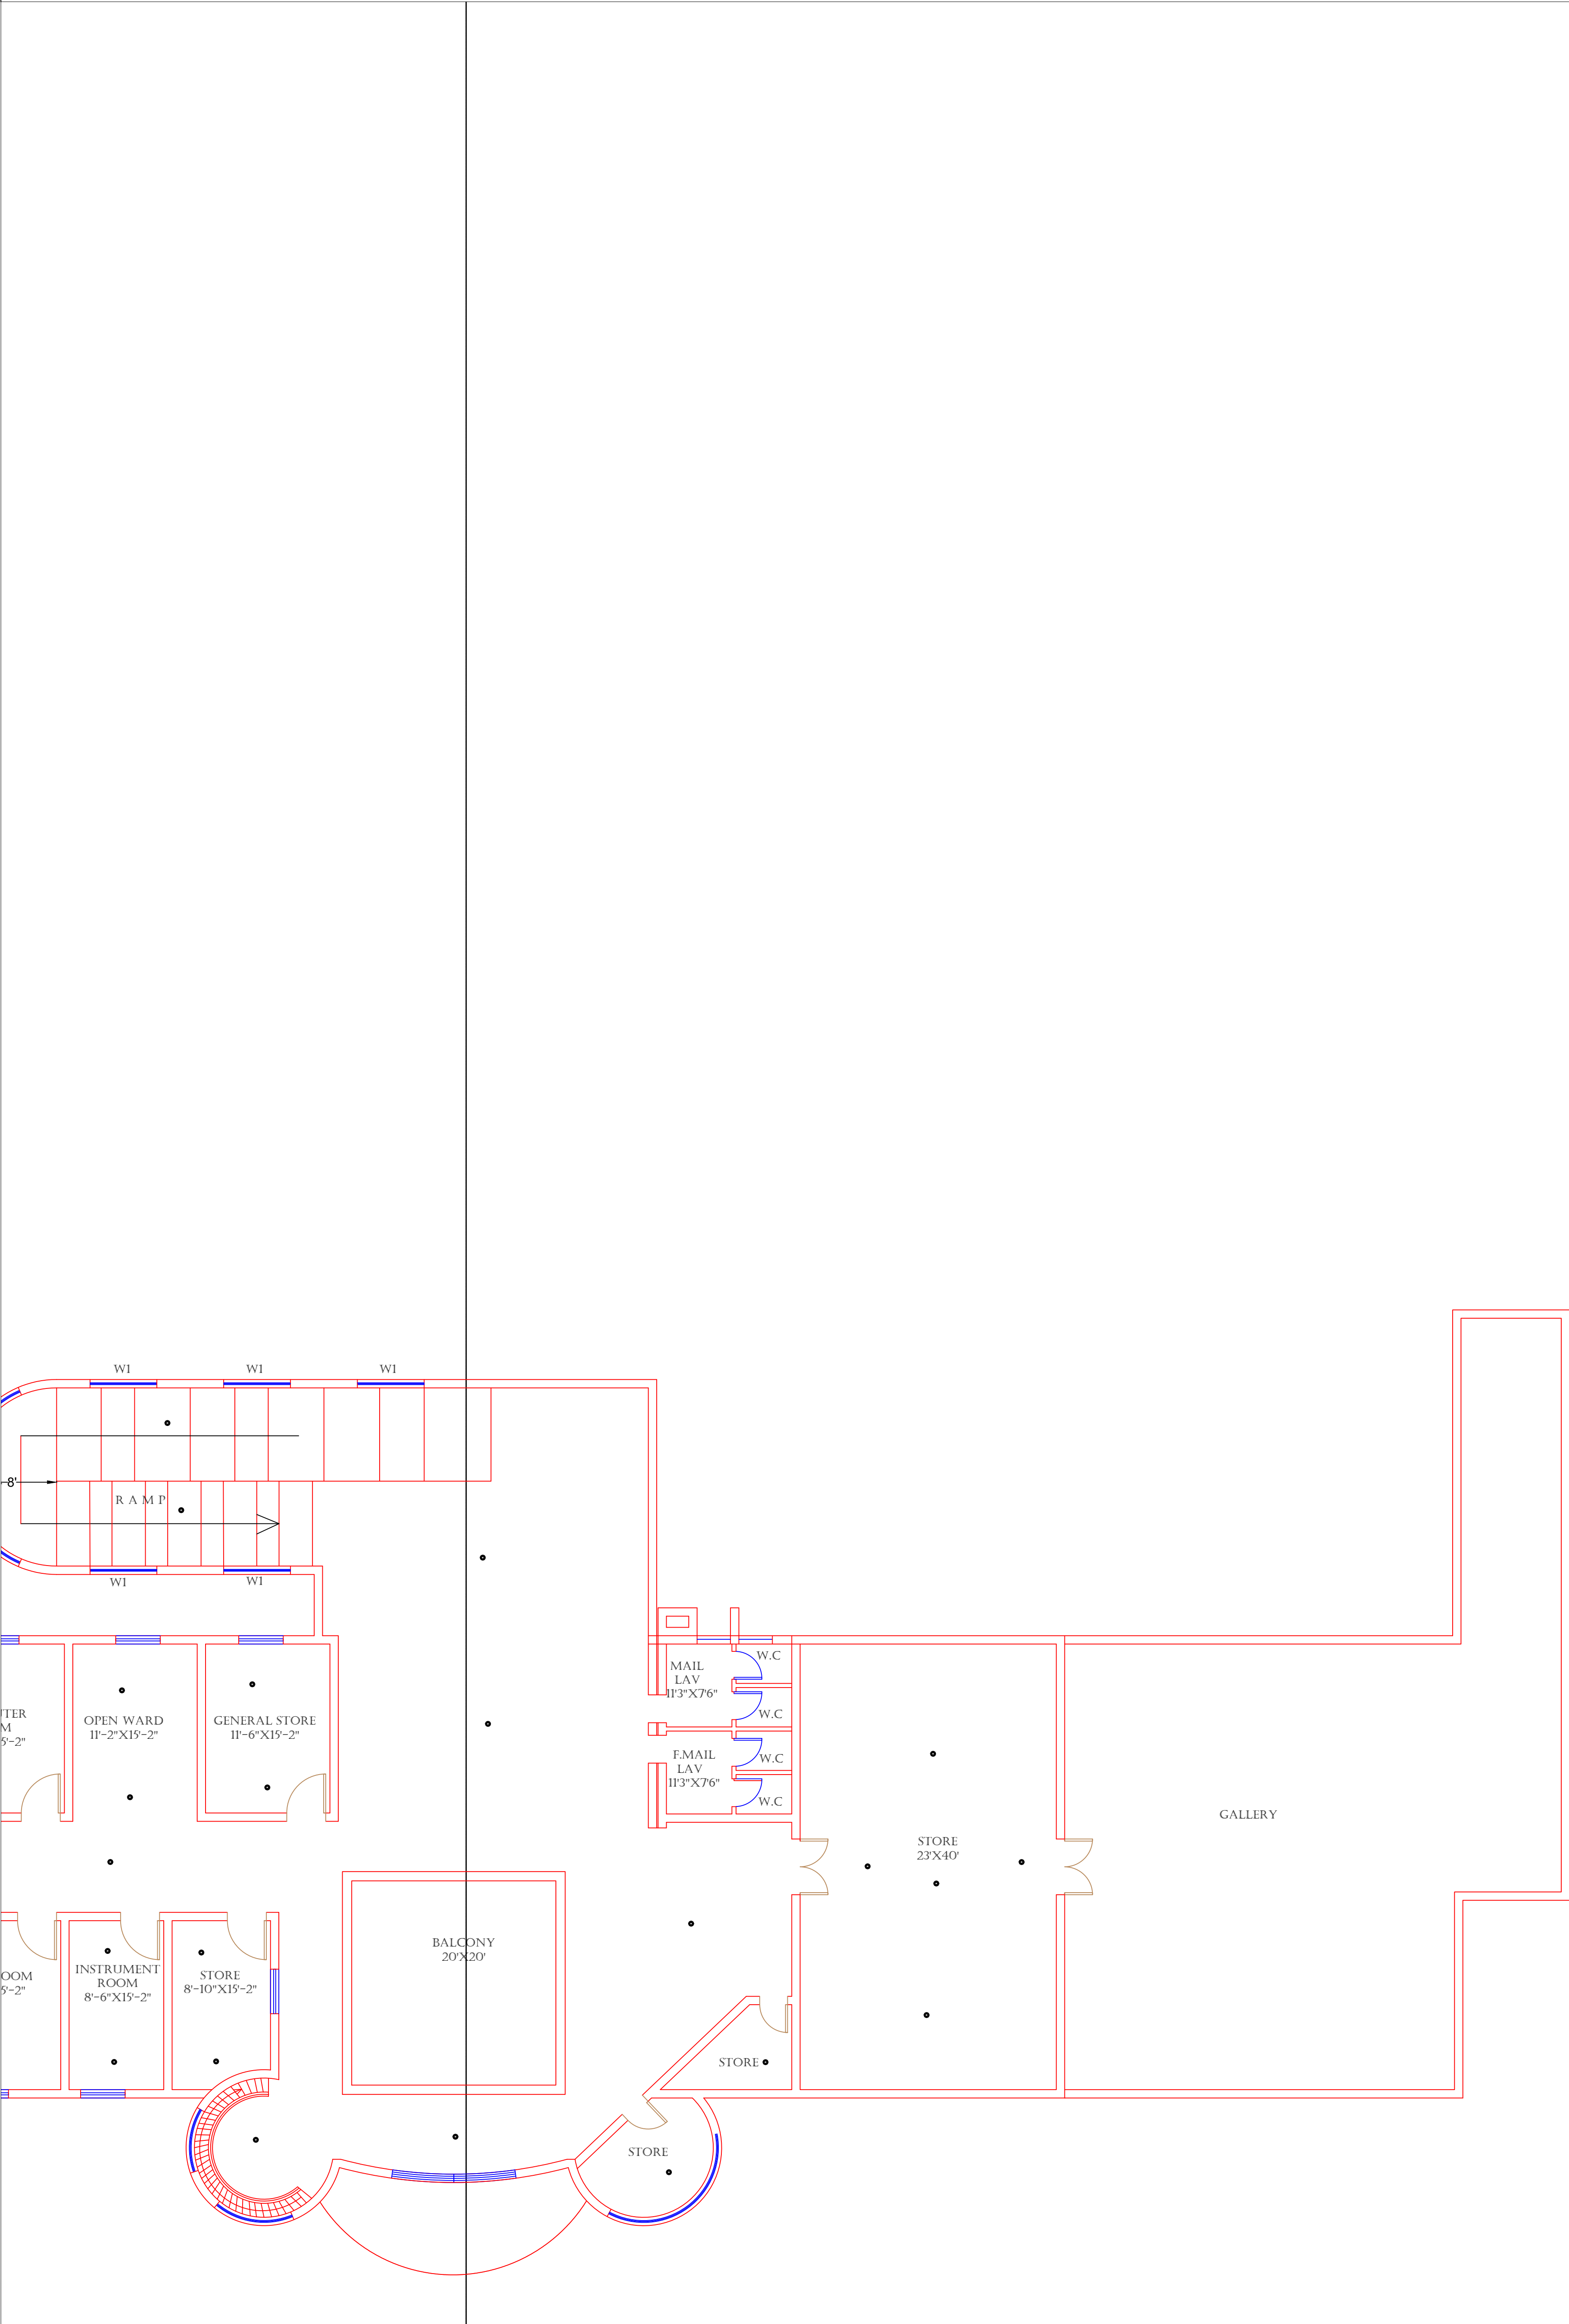

Legends:

RESIDENTIAL AREA	
ROAD	
WALL	
POWER LINE	
OHT	
TREE	
MANHOLE	
TUBE WELL	
LIGHT POLE	
LAWNS	
EARTHEN AREAS	
ASPHALTS ROADS	
TOUGH PAVERS	
P.C.C. /PLINTH PROTECTION	
BOUNDARY WALL	
TAP	
HAND PUMP	
BRICK PAVERS	
AIR CONDITIONER	
TUBE LIGHT	
FAN	
ROOF LIGHT	
BULB	

AREA	
AREA WITHIN BOUNDARY WALL	32248413.6913 SFT
AREA OF CLINICAL BLOCK	18965778.5977 SFT
PLINTH AREA OF BLOCK	13470334.8618 SFT

OPENING SCHEDULE OF DOORS AND WINDOWS					
DOORS	WIDTH	HEIGHT	WINDOWS	WIDTH	HEIGHT
D1	5'-0"	7'-0"	W1	6'-0"	6'-0"
D2	3'-6"	7'-0"	W2	4'-0"	4'-0"
D3	2'-0"	7'-0"	W3	3'-0"	5'-0"
D4	8'-0"	7'-0"	W4	2'-0"	2'-0"
D5			W5		
D6			W6		
D7			W7		
D8			V1		
D9			V2		

Client:


GOVERNMENT OF THE PUNJAB
PRIMARY & SECONDARY
HEALTHCARE DEPARTMENT

Project:

CAD MAPPING OF TEHSIL
HEAD QUARTER HOSPITALS,
PUNJAB

Consultant:


SKAFS CONSULTANT (Pvt.) Limited
ENGINEERING AND ENVIRONMENT CONSULTANT

Drawing Title:


THQ KOTMOMIN
HOSPITAL CLINICAL BLOCK
PART 4

Authorized By: SKAFS	Reviewed By Co-Team Leader	Scale:
Prepared By: CAD TEAMS	Date: FEB, 2017	

Drawing No. **SKAFS/KOTMOMIN /14**

ELECTRICAL LAYOUT PLAN OF THQ HOSPITAL KOT MOMIN

GROUND FLOOR

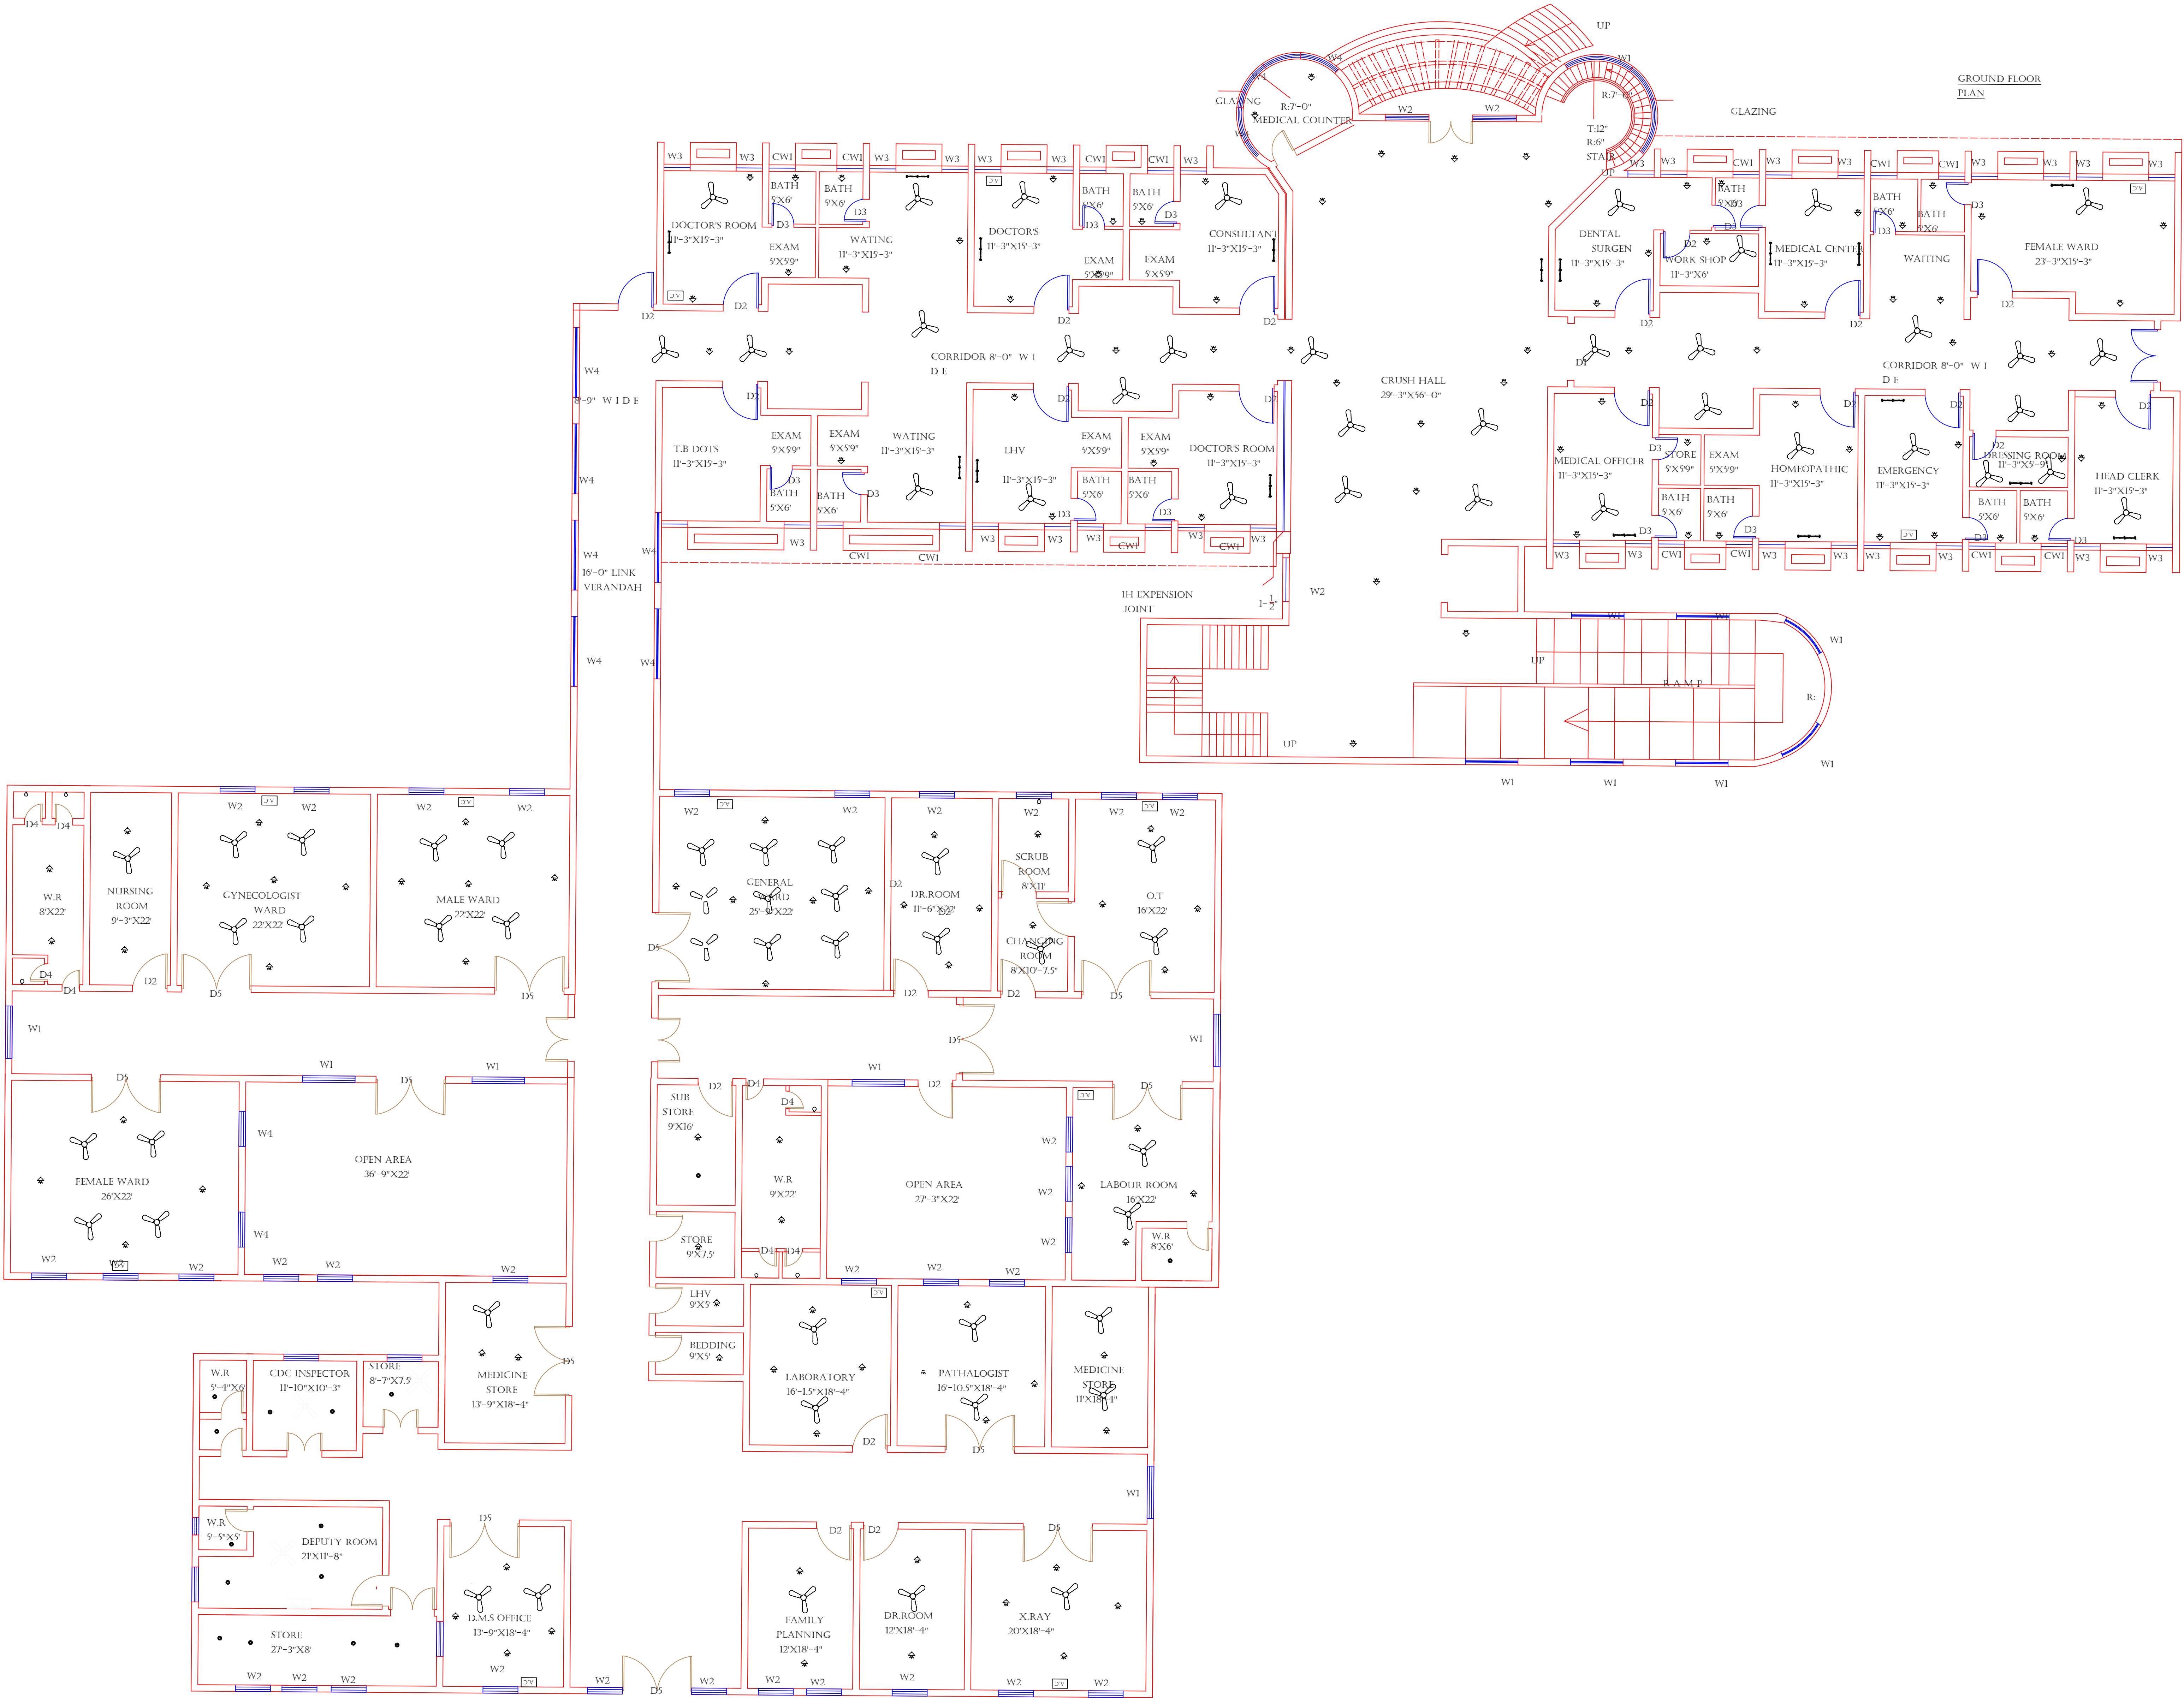

Legends:

RESIDENTIAL AREA	
ROAD	
WALL	
POWER LINE	
OHT	
TREE	
MANHOLE	
TUBE WELL	
LIGHT POLE	
LAWNS	
EARTHEN AREAS	
ASPHALTS ROADS	
TOUGH PAVERS	
P.C.C /PLINTH PROTECTION	
BOUNDARY WALL	
TAP	
HAND PUMP	
BRICK PAVERS	
AIR CONDITIONER	
TUBE LIGHT	
FAN	
ROOF LIGHT	
BULB	

AREA	
AREA WITHIN BOUNDARY WALL	32248413.6913 SFT
AREA OF CLINICAL BLOCK	18965778.5977 SFT
PLINTH AREA OF BLOCK	13470334.8618 SFT

OPENING SCHEDULE OF DOORS AND WINDOWS					
DOORS	WIDTH	HEIGHT	WINDOWS	WIDTH	HEIGHT
D1	5'-0"	7'-0"	W1	6'-0"	6'-0"
D2	3'-6"	7'-0"	W2	4'-0"	4'-0"
D3	2'-0"	7'-0"	W3	3'-0"	5'-0"
D4	8'-0"	7'-0"	W4	2'-0"	2'-0"
D5			W5		
D6			W6		
D7			W7		
D8			V1		
D9			V2		

Client:



GOVERNMENT OF THE PUNJAB
PRIMARY & SECONDARY
HEALTHCARE DEPARTMENT

Project:

CAD MAPPING OF TEHSIL
HEAD QUARTER HOSPITALS,
PUNJAB

Consultant:




SKAFS CONSULTANT (Pvt.) Limited
ENGINEERING AND ENVIRONMENT CONSULTANT

Drawing Title:



THQ KOTMOMIN
ELECTRICAL LAYOUT
GROUND FLOOR

Authorized By: SKAFS	Reviewed By Co-Team Leader	Scale:
Prepared By: CAD TEAMS	Date: FEB, 2017	
Drawing No. SKAFS/KOTMOMIN /15		

ELECTRICAL LAYOUT PLAN OF THQ HOSPITAL KOT MOMIN FIRST FLOOR

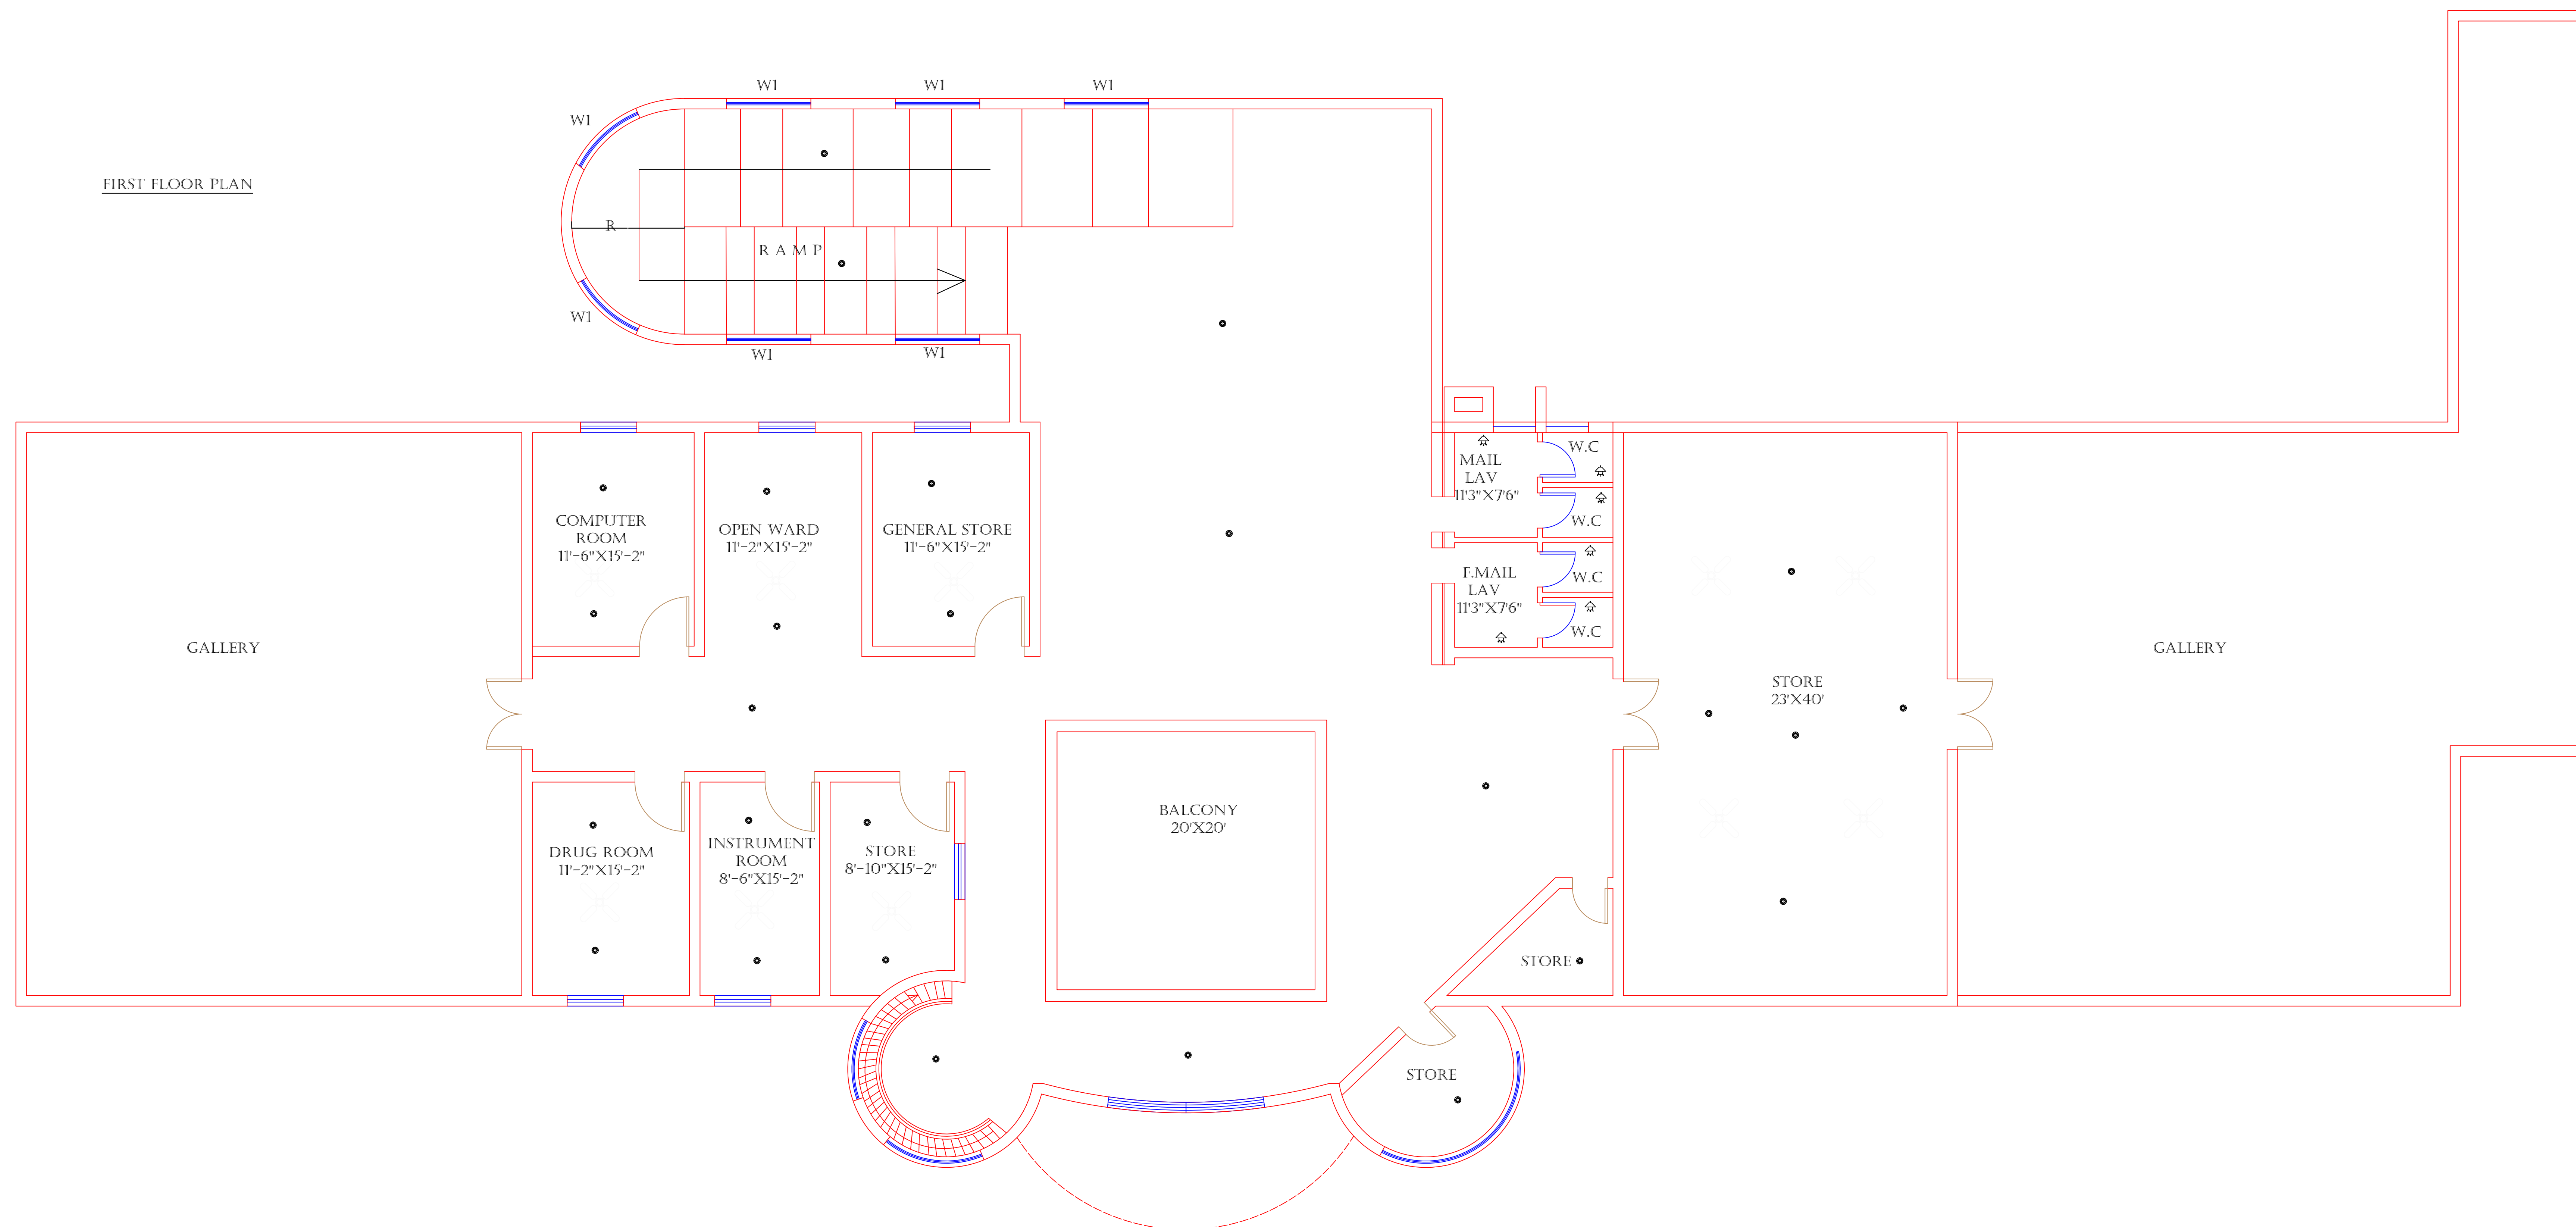

Legends:

  RESIDENTIAL AREA	
ROAD	
WALL	
POWER LINE	
OHT	
TREE	
MANHOLE	
TUBE WELL	
LIGHT POLE	
LAWNS	
EARTHEN AREAS	
ASPHALTS ROADS	
TOUGH PAVERS	
P.C.C /PLINTH PROTECTION	
BOUNDARY WALL	
TAP	
HAND PUMP	
BRICK PAVERS	
AIR CONDITIONER	
TUBE LIGHT	
FAN	
ROOF LIGHT	
BULB	

AREA	
AREA WITHIN BOUNDARY WALL	32248413.6913 SFT
AREA OF CLINICAL BLOCK	18965778.5977 SFT
PLINTH AREA OF BLOCK	13470334.8618 SFT

OPENING SCHEDULE OF DOORS AND WINDOWS					
DOORS	WIDTH	HEIGHT	WINDOWS	WIDTH	HEIGHT
D1	5'-0"	7'-0"	W1	6'-0"	6'-0"
D2	3'-6"	7'-0"	W2	4'-0"	4'-0"
D3	2'-0"	7'-0"	W3	3'-0"	5'-0"
D4	8'-0"	7'-0"	W4	2'-0"	2'-0"
D5			W5		
D6			W6		
D7			W7		
D8			V1		
D9			V2		

Client:



GOVERNMENT OF THE PUNJAB
PRIMARY & SECONDARY
HEALTHCARE DEPARTMENT

Project:

CAD MAPPING OF TEHSIL HEAD QUARTER HOSPITALS, PUNJAB

Consultant:



SKAFS CONSULTANT (Pvt.) Limited
ENGINEERING AND ENVIRONMENT CONSULTANT

Drawing Title: **THQ KOTMOMIN
ELECTRICAL LAYOUT
FIRST FLOOR**

Authorized By: SKAFS	Reviewed By Co-Team Leader	Scale:
Prepared By: CAD TEAMS	Date: FEB, 2017	

Drawing No.	SKAFS/KOTMOMIN /16
-------------	---------------------------