

MASTER PLAN OF THQ HOSPITAL SHAKARGARH

PART 1

PART 2

PART 3

PART 4



Legends:

Residential Area	
Road	
Wall	
Power Line	
OHT	
Tree	
Man Hole	
Tube Well	
Light Pole	
Lawns	
Earthen Areas	
Asphalts Roads	
Tough Pavers	
P.C.C / Plinth Protection	
Boundary Wall	
Brick Pavers / Soling	
Drain	
Tap	
Hand Pump	
Air Conditioner	
Tube Light	
Fan	
Roof Light	
Bulb	

AREA	
AREA WITHIN BOUNDARY WALL	159448.927 Sft
AREA OF CLINICAL BLOCK	34202.314 Sft
PLINTH AREA OF BLOCK	34202.314 Sft

OPENING SCHEDULE OF DOORS AND WINDOWS					
DOORS	WIDTH	HEIGHT	WINDOWS	WIDTH	HEIGHT
D1	5'-0"	7'-0"	W1	6'-0"	6'-0"
D2	3'-6"	7'-0"	W2	5'-0"	5'-0"
D3	2'-6"	7'-0"	W3	3'-0"	3'-0"
D4			W4	2'-0"	2'-0"
D5			W5	8'-0"	8'-0"
D6					
D7					
D8					
D9					

Project:
**CAD MAPPING OF TEHSIL
HEAD QUARTER HOSPITALS,
PUNJAB**



Client: GOVERNMENT OF THE PUNJAB PRIMARY & SECONDARY HEALTHCARE DEPARTMENT	Consultant: SKAFS CONSULTANT (Pvt.) Limited ENGINEERING AND ENVIRONMENT CONSULTANT
---	--

Drawing Title:
**THQ SHAKARGARH
HOSPITAL MASTER PLAN**

Drawing No.
SKAFS/SHAKARGARH/03

MASTER PLAN OF THQ HOSPITAL SHAKARGARH

PART 1

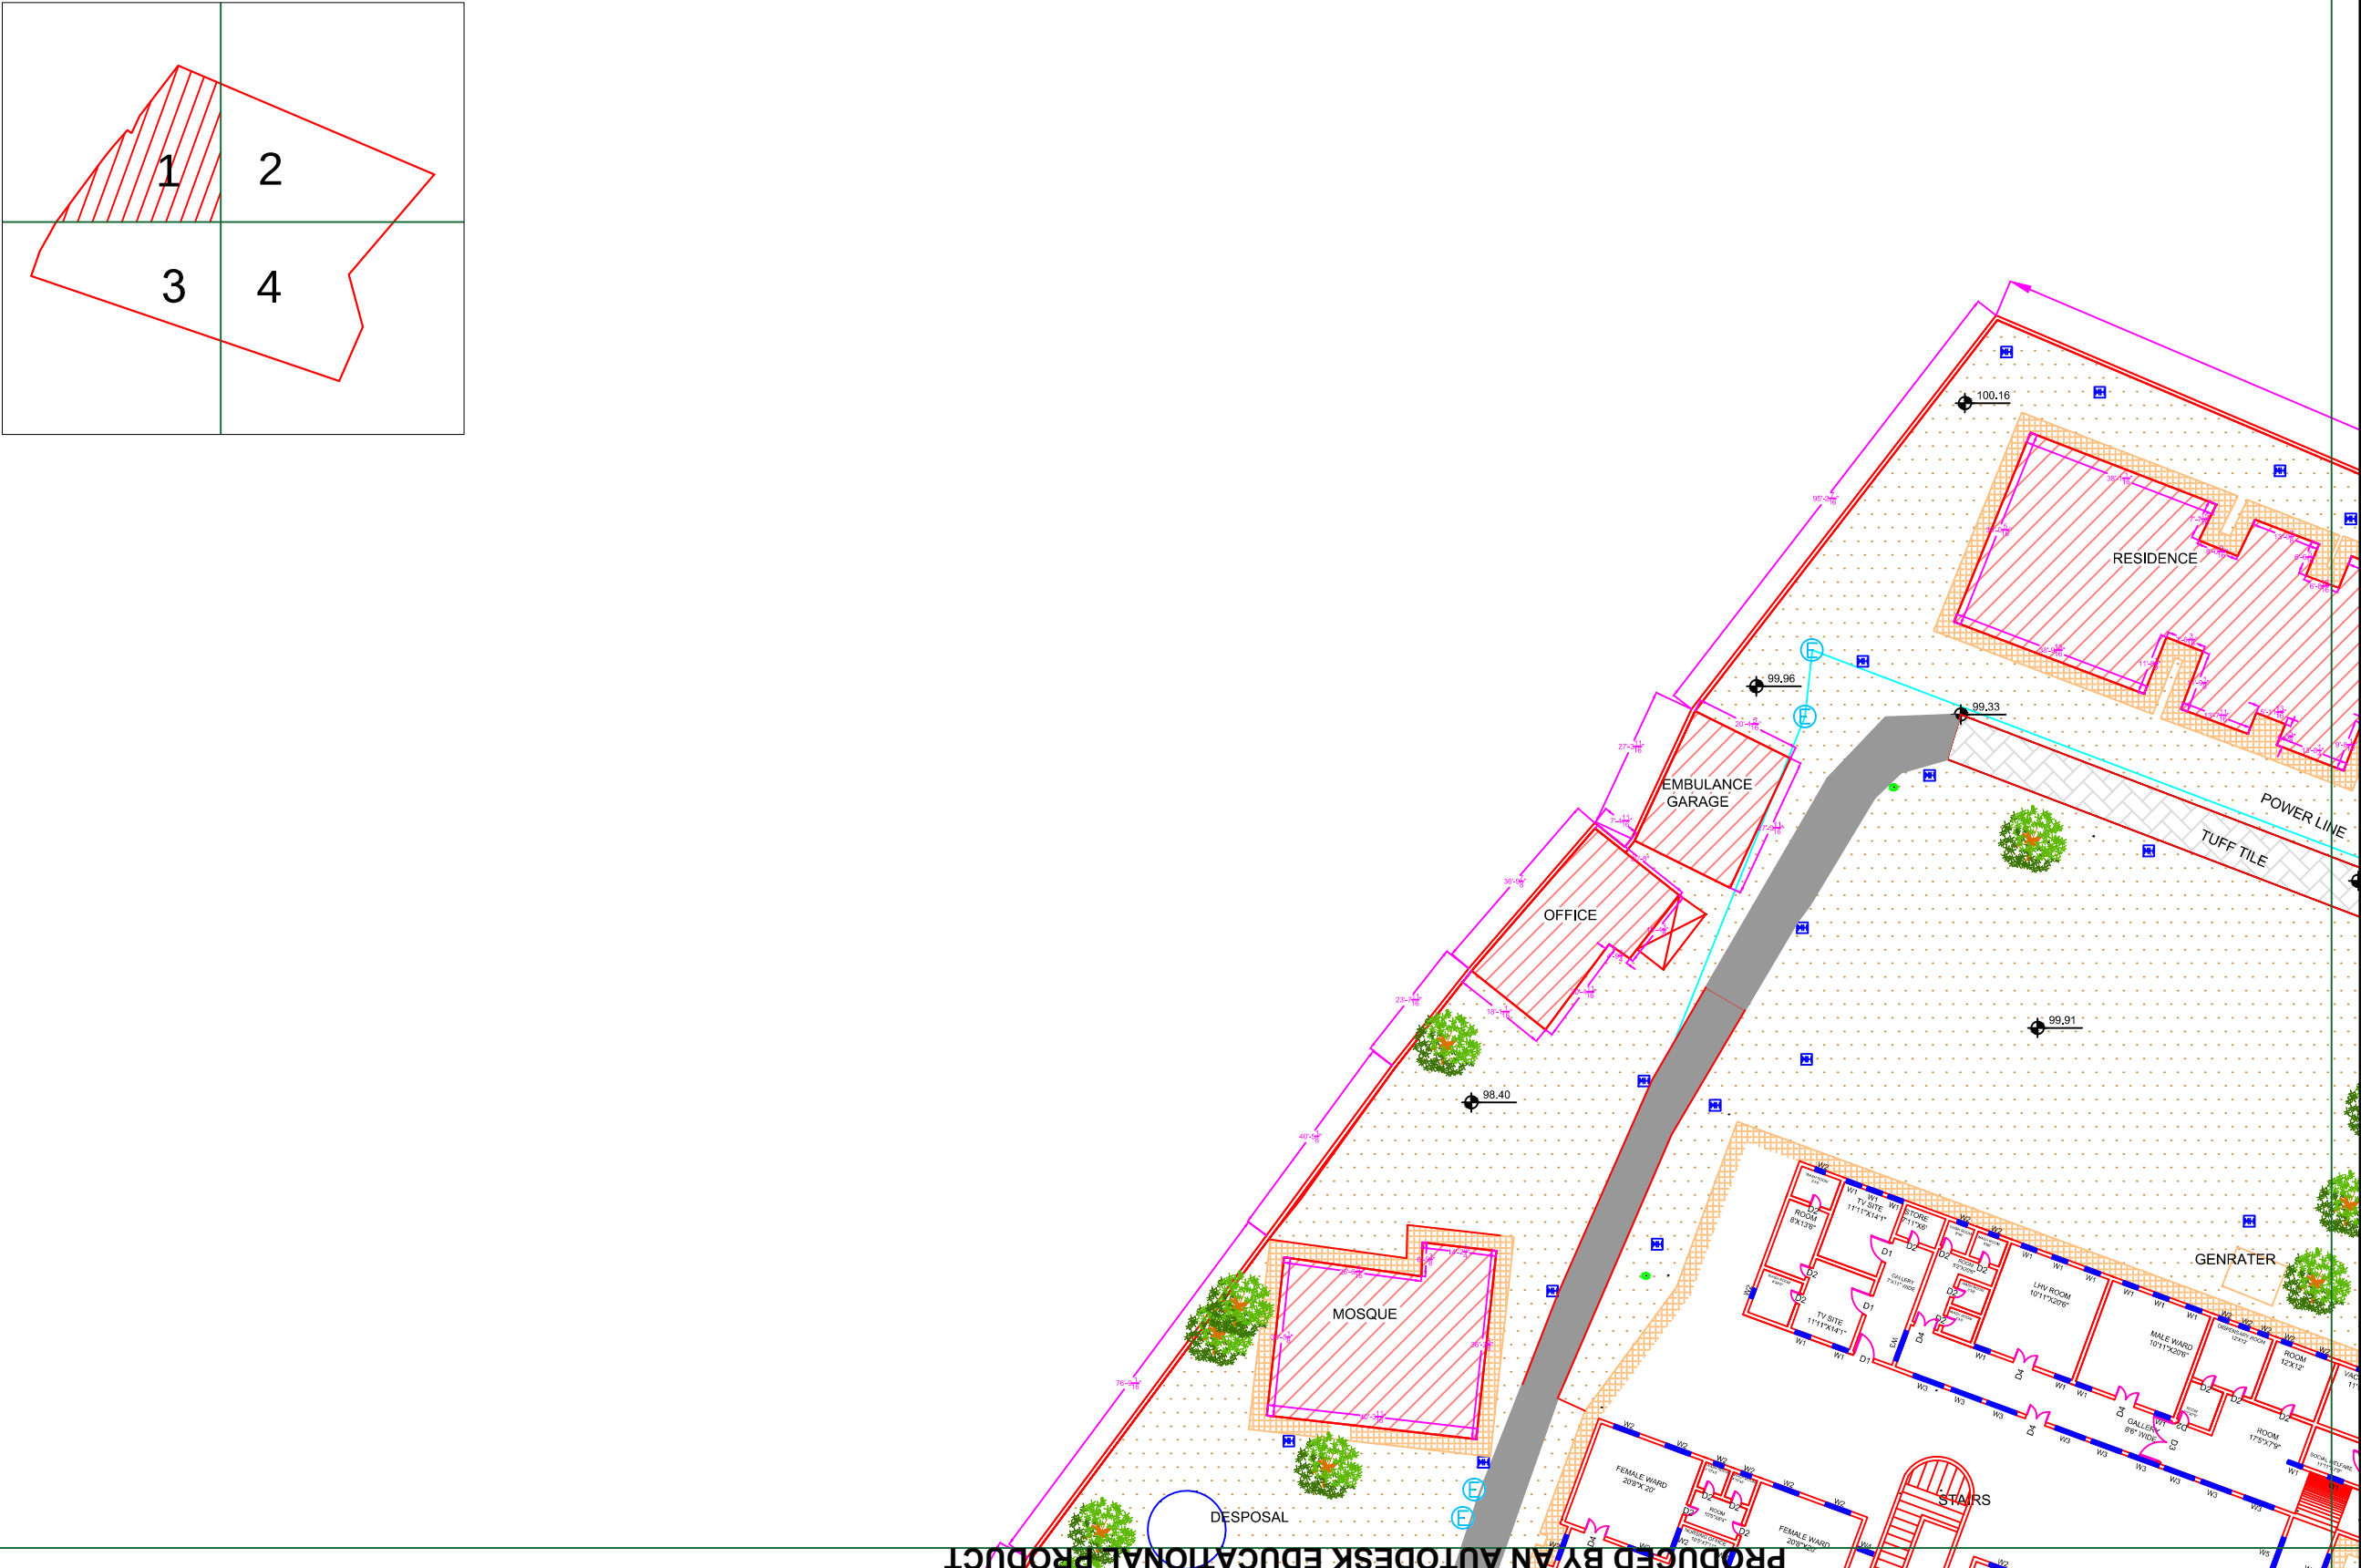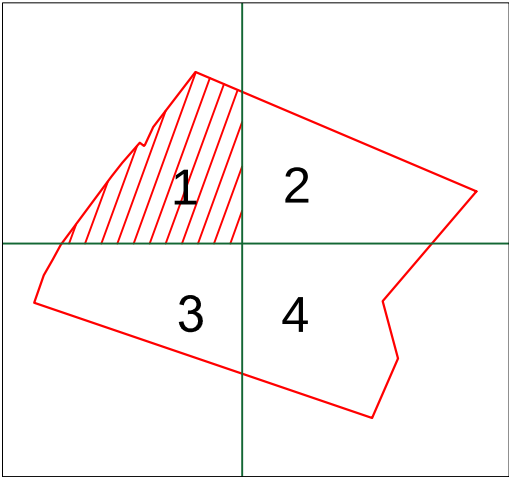

Legends:	
Residential Area	
Road	
Wall	
Power Line	
OHT	
Tree	
Man Hole	
Tube Well	
Light Pole	
Lawns	
Earthen Areas	
Asphalts Roads	
Tough Pavers	
P.C.C / Plinth Protection	
Boundary Wall	
Brick Pavers / Soling	
Drain	
Tap	
Hand Pump	
Air Conditioner	
Tube Light	
Fan	
Roof Light	
Bulb	

AREA	
AREA WITHIN BOUNDARY WALL	159448.927 Sft
AREA OF CLINICAL BLOCK	34202.314 Sft
PLINTH AREA OF BLOCK	34202.314 Sft

OPENING SCHEDULE OF DOORS AND WINDOWS					
DOORS	WIDTH	HEIGHT	WINDOWS	WIDTH	HEIGHT
D1	5'-0"	7'-0"	W1	6'-0"	6'-0"
D2	3'-6"	7'-0"	W2	5'-0"	5'-0"
D3	2'-6"	7'-0"	W3	3'-0"	3'-0"
D4			W4	2'-0"	2'-0"
D5			W5	8'-0"	8'-0"
D6					
D7					
D8					
D9					

Project:
**CAD MAPPING OF TEHSIL
HEAD QUARTER HOSPITALS,
PUNJAB**

Client: GOVERNMENT OF THE PUNJAB PRIMARY & SECONDARY HEALTHCARE DEPARTMENT	Consultant: SKAFS CONSULTANT (Pvt.) Limited ENGINEERING AND ENVIRONMENT CONSULTANT
---	--



Drawing Title:
**THQ SHAKARGARH
HOSPITAL MASTER PLAN PART 1**

Drawing No.
SKAFS/SHAKARGARH/04

MASTER PLAN OF THQ HOSPITAL SHAKARGARH

PART 2

PRODUCED BY AN AUTODESK EDUCATIONAL PRODUCT

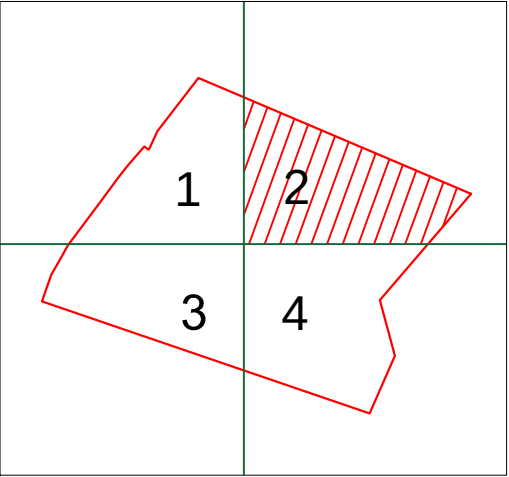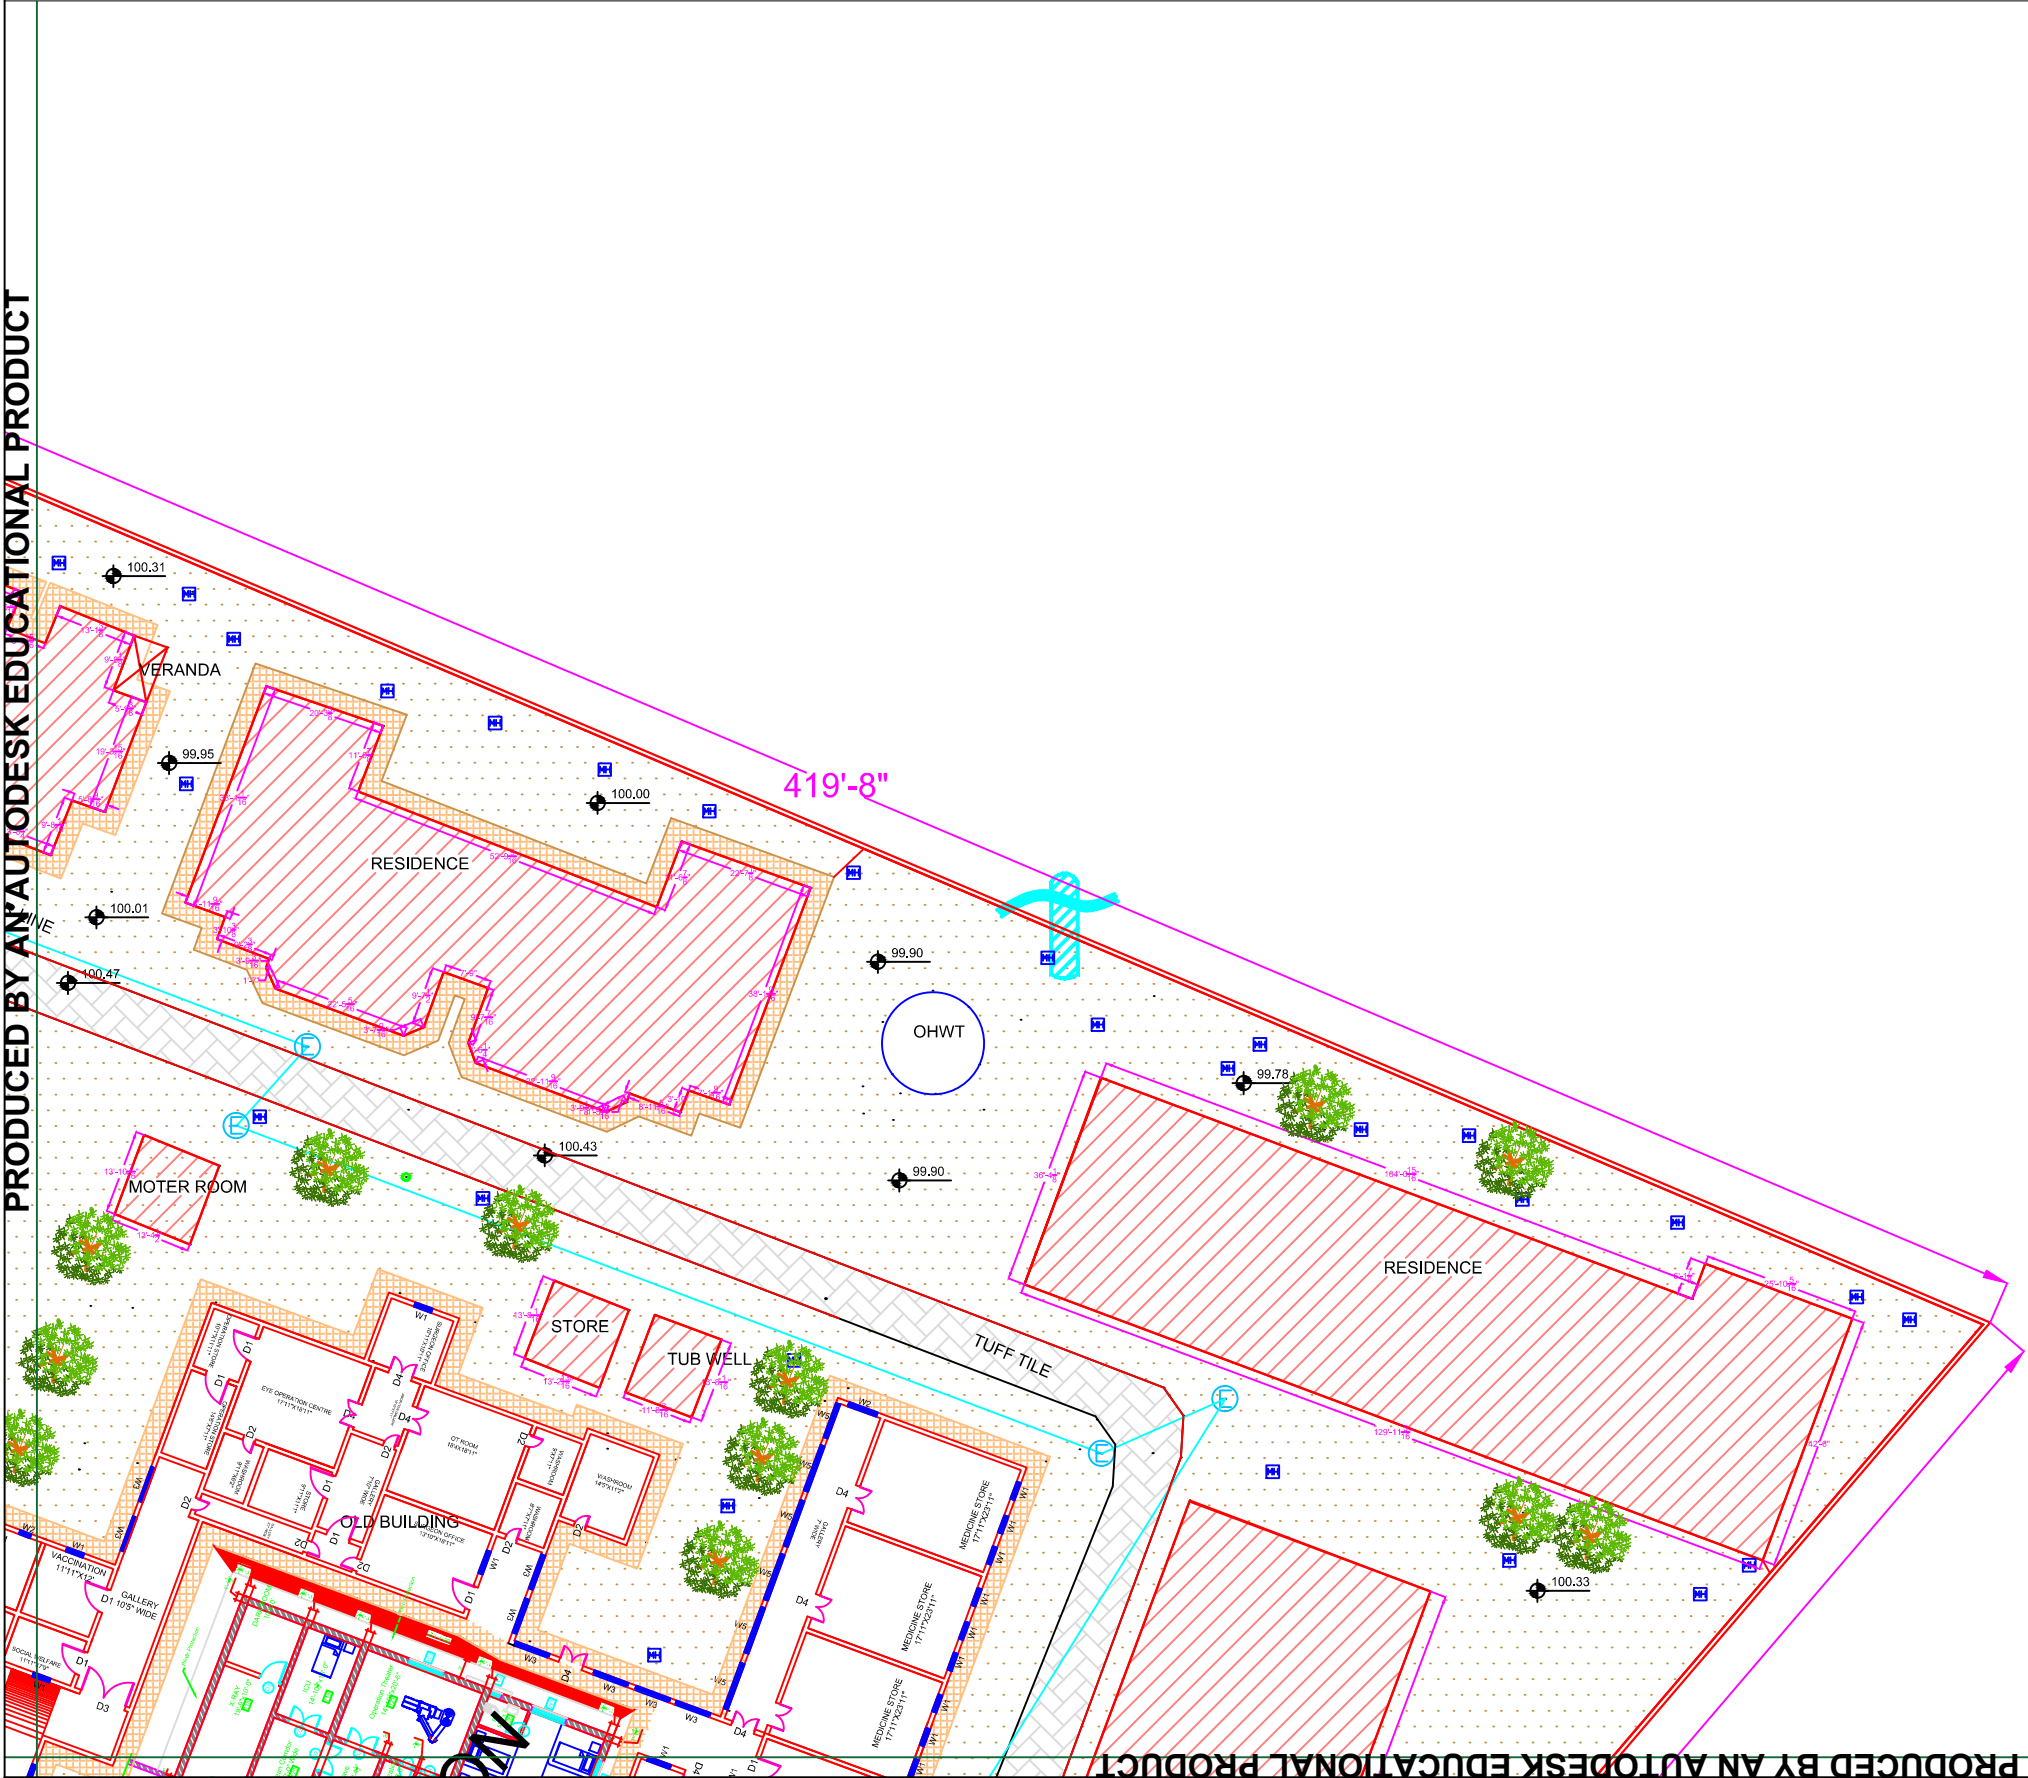

Legends:

Residential Area	
Road	
Wall	
Power Line	
OHT	
Tree	
Man Hole	
Tube Well	
Light Pole	
Lawns	
Earthen Areas	
Asphalts Roads	
Tough Pavers	
P.C.C / Plinth Protection	
Boundary Wall	
Brick Pavers / Soling	
Drain	
Tap	
Hand Pump	
Air Conditioner	
Tube Light	
Fan	
Roof Light	
Bulb	

PRODUCED BY AN AUTODESK EDUCATIONAL PRODUCT

AREA	
AREA WITHIN BOUNDARY WALL	159448.927 Sft
AREA OF CLINICAL BLOCK	34202.314 Sft
PLINTH AREA OF BLOCK	34202.314 Sft

OPENING SCHEDULE OF DOORS AND WINDOWS					
DOORS	WIDTH	HEIGHT	WINDOWS	WIDTH	HEIGHT
D1	5'-0"	7'-0"	W1	6'-0"	6'-0"
D2	3'-6"	7'-0"	W2	5'-0"	5'-0"
D3	2'-6"	7'-0"	W3	3'-0"	3'-0"
D4			W4	2'-0"	2'-0"
D5			W5	8'-0"	8'-0"
D6					
D7					
D8					
D9					

Project:
**CAD MAPPING OF TEHSIL
HEAD QUARTER HOSPITALS,
PUNJAB**

Client: GOVERNMENT OF THE PUNJAB PRIMARY & SECONDARY HEALTHCARE DEPARTMENT	Consultant: SKAFS CONSULTANT (Pvt.) Limited ENGINEERING AND ENVIRONMENT CONSULTANT
---	--

Drawing Title:
**THQ SHAKARGARH
HOSPITAL MASTER PLAN PART 2**

Drawing No.
SKAFS/SHAKARGARH/05

MASTER PLAN OF THQ HOSPITAL SHAKARGARH

PART 3


PRODUCED BY AN AUTODESK EDUCATIONAL PRODUCT



Legends:

Residential Area	
Road	
Wall	
Power Line	
OHT	
Tree	
Man Hole	
Tube Well	
Light Pole	
Lawns	
Earthen Areas	
Asphalts Roads	
Tough Pavers	
P.C.C / Plinth Protection	
Boundary Wall	
Brick Pavers / Soling	
Drain	
Tap	
Hand Pump	
Air Conditioner	
Tube Light	
Fan	
Roof Light	
Bulb	

PRODUCED BY AN AUTODESK EDUCATIONAL PRODUCT

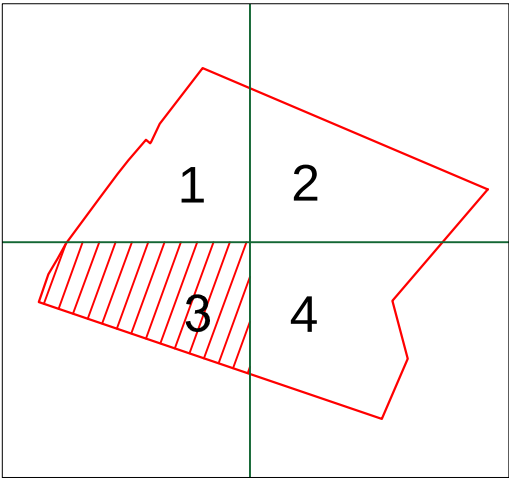

AREA	
AREA WITHIN BOUNDARY WALL	159448.927 Sft
AREA OF CLINICAL BLOCK	34202.314 Sft
PLINTH AREA OF BLOCK	34202.314 Sft

OPENING SCHEDULE OF DOORS AND WINDOWS					
DOORS	WIDTH	HEIGHT	WINDOWS	WIDTH	HEIGHT
D1	5'-0"	7'-0"	W1	6'-0"	6'-0"
D2	3'-6"	7'-0"	W2	5'-0"	5'-0"
D3	2'-6"	7'-0"	W3	3'-0"	3'-0"
D4			W4	2'-0"	2'-0"
D5			W5	8'-0"	8'-0"
D6					
D7					
D8					
D9					

Project:
**CAD MAPPING OF TEHSIL
HEAD QUARTER HOSPITALS,
PUNJAB**


Client: GOVERNMENT OF THE PUNJAB PRIMARY & SECONDARY HEALTHCARE DEPARTMENT	Consultant: SKAFS CONSULTANT (Pvt.) Limited ENGINEERING AND ENVIRONMENT CONSULTANT
---	--

Drawing Title:
**THQ SHAKARGARH
HOSPITAL MASTER PLAN PART 3**

Drawing No.
SKAFS/SHAKARGARH/06

MASTER PLAN OF THQ HOSPITAL SHAKARGARH

PART 4

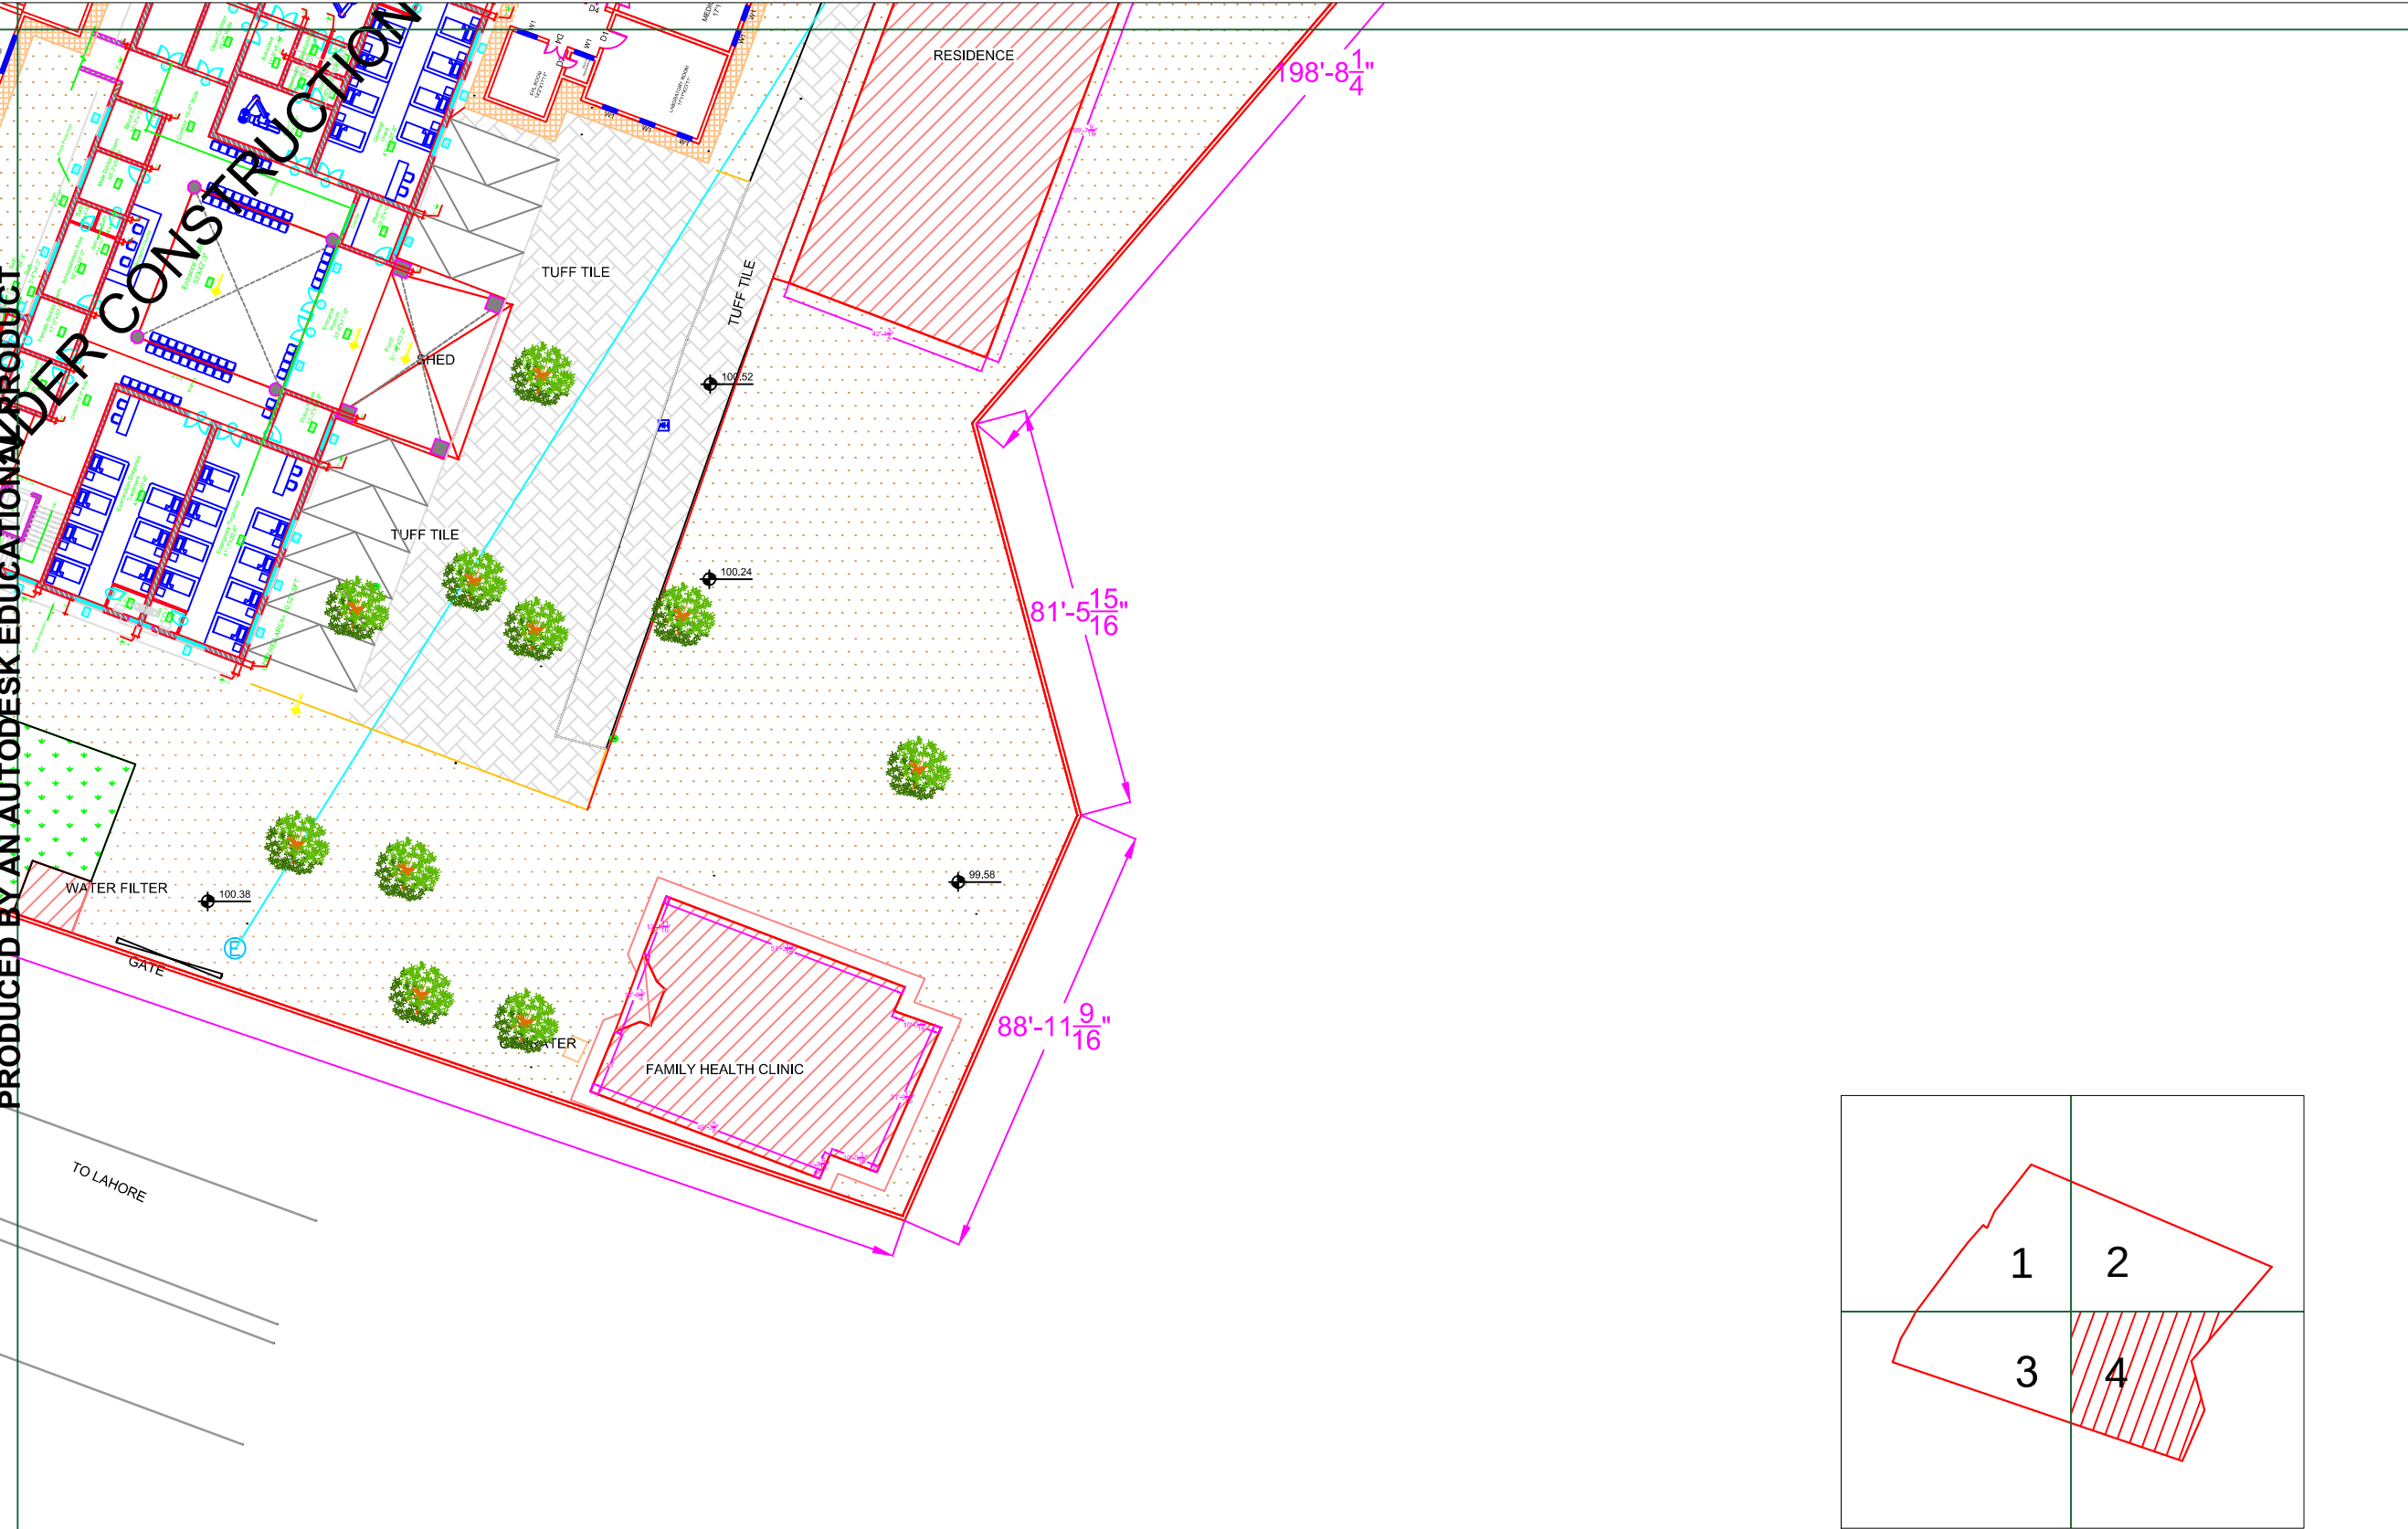

Legends:

Residential Area	
Road	
Wall	
Power Line	
OHT	
Tree	
Man Hole	
Tube Well	
Light Pole	
Lawns	
Earthen Areas	
Asphalts Roads	
Tough Pavers	
P.C.C / Plinth Protection	
Boundary Wall	
Brick Pavers / Soling	
Drain	
Tap	
Hand Pump	
Air Conditioner	
Tube Light	
Fan	
Roof Light	
Bulb	

AREA	
AREA WITHIN BOUNDARY WALL	159448.927 Sft
AREA OF CLINICAL BLOCK	34202.314 Sft
PLINTH AREA OF BLOCK	34202.314 Sft


OPENING SCHEDULE OF DOORS AND WINDOWS					
DOORS	WIDTH	HEIGHT	WINDOWS	WIDTH	HEIGHT
D1	5'-0"	7'-0"	W1	6'-0"	6'-0"
D2	3'-6"	7'-0"	W2	5'-0"	5'-0"
D3	2'-6"	7'-0"	W3	3'-0"	3'-0"
D4			W4	2'-0"	2'-0"
D5			W5	8'-0"	8'-0"
D6					
D7					
D8					
D9					

Project:
**CAD MAPPING OF TEHSIL
HEAD QUARTER HOSPITALS,
PUNJAB**

Client: GOVERNMENT OF THE PUNJAB PRIMARY & SECONDARY HEALTHCARE DEPARTMENT	Consultant: SKAFS CONSULTANT (Pvt.) Limited ENGINEERING AND ENVIRONMENT CONSULTANT
---	--

Drawing Title:
**THQ SHAKARGARH
HOSPITAL MASTER PLAN PART 4**

Drawing No.
SKAFS/SHAKARGARH/07

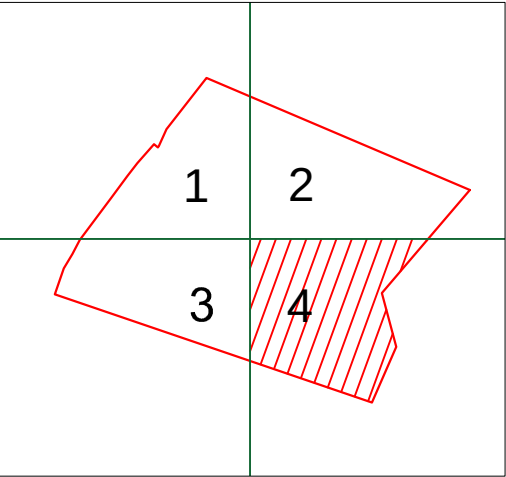

PRODUCED BY AN AUTODESK EDUCATIONAL PRODUCT



PRODUCED BY AN AUTODESK EDUCATIONAL PRODUCT

CLINICAL BLOCK OF THQ HOSPITAL SHAKARGARH


GROUND FLOOR

PART 1

PART 2

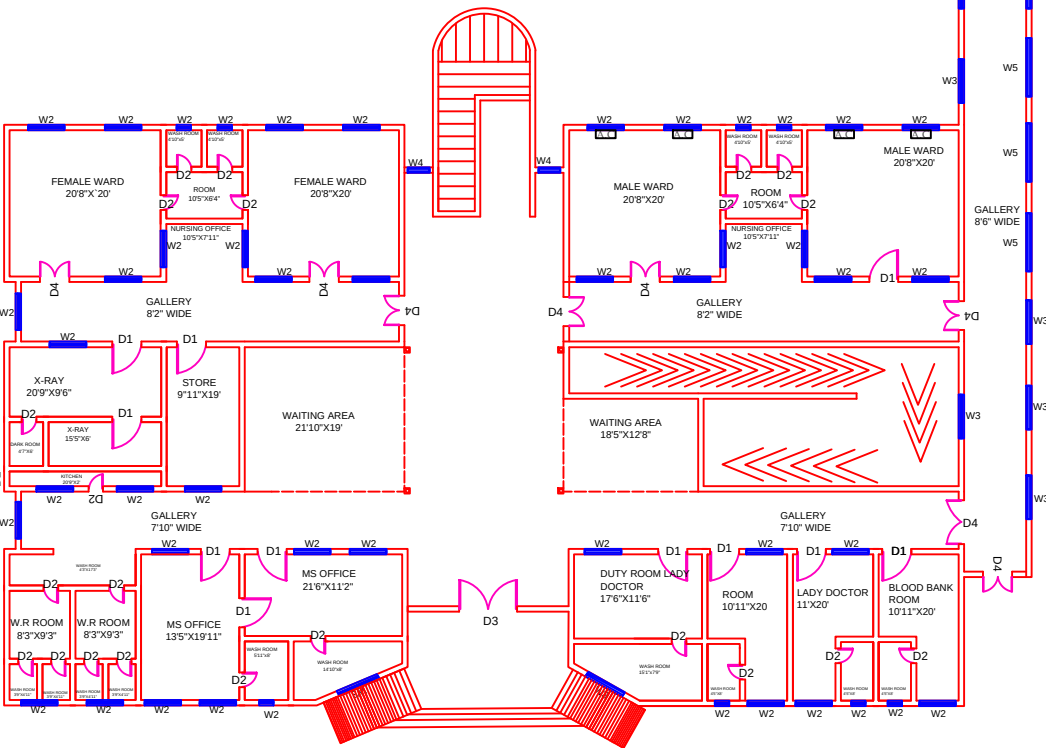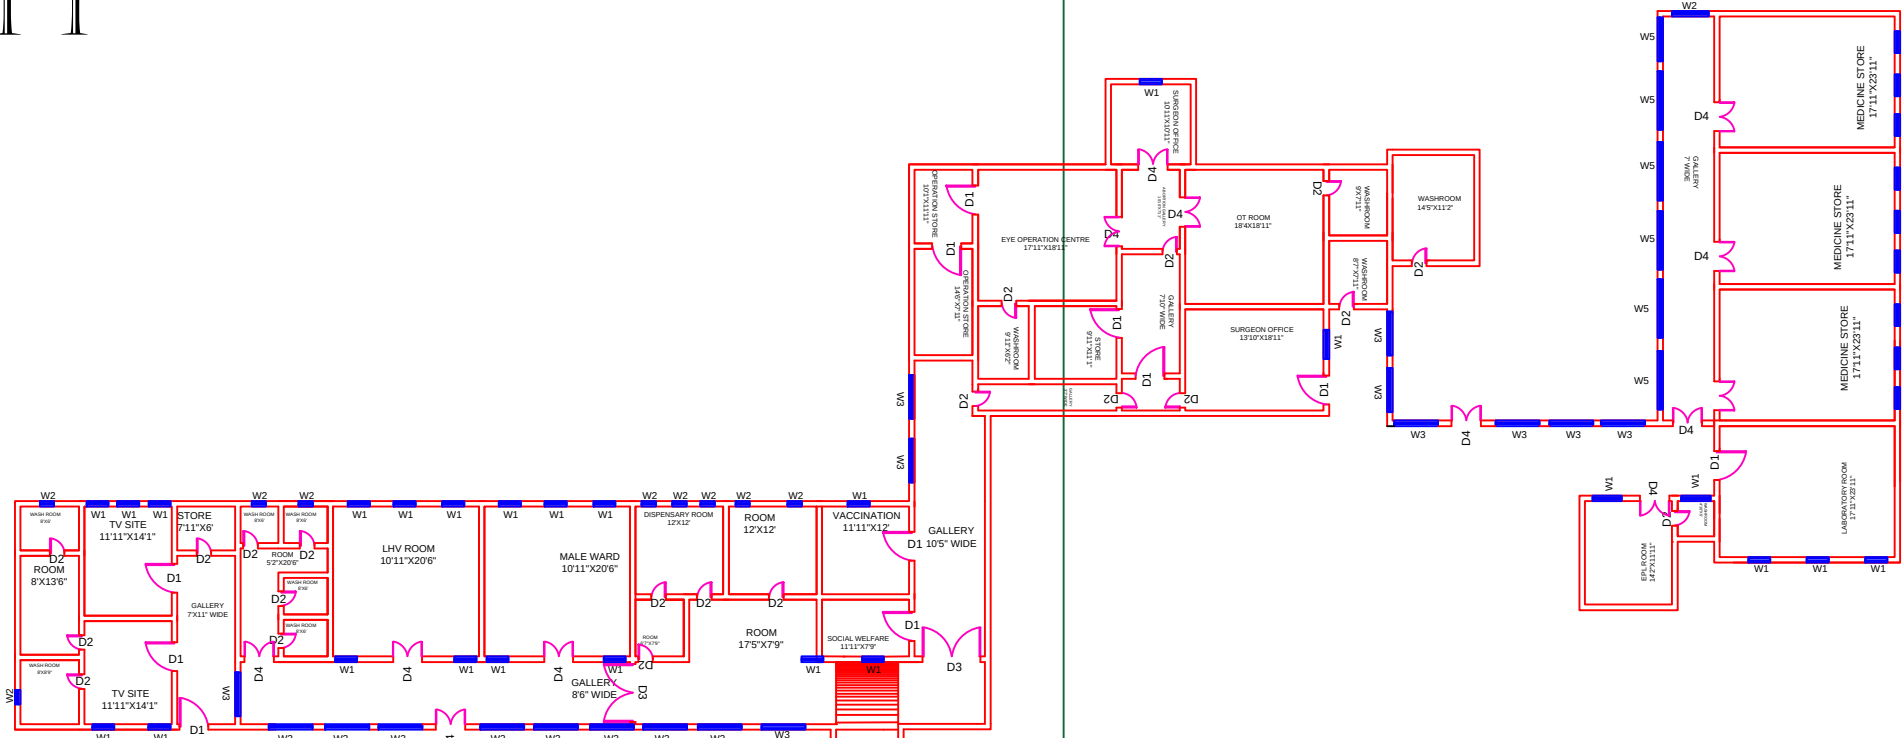

PART 3

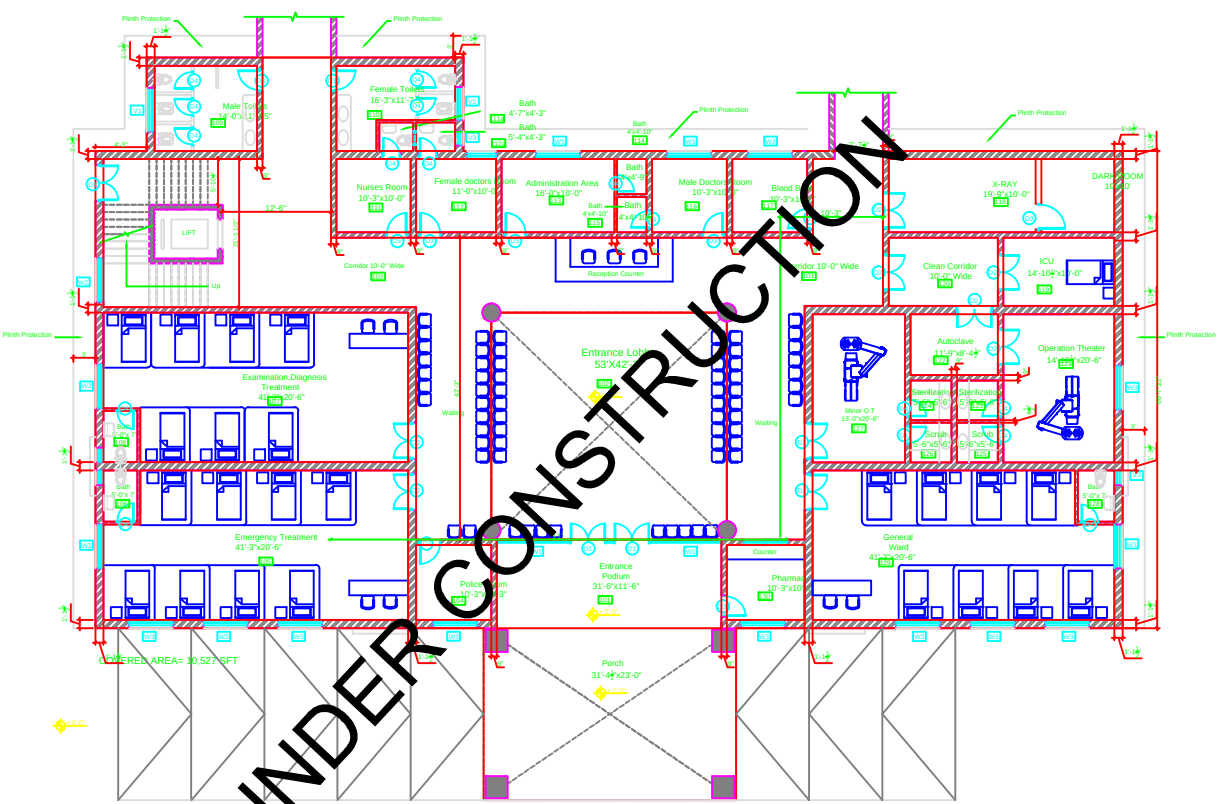

PART 4

Legends:

Residential Area	
Road	
Wall	
Power Line	
OHT	
Tree	
Man Hole	
Tube Well	
Light Pole	
Lawns	
Earthen Areas	
Asphalts Roads	
Tough Pavers	
P.C.C / Plinth Protection	
Boundary Wall	
Brick Pavers / Soling	
Drain	
Tap	
Hand Pump	
Air Conditioner	
Tube Light	
Fan	
Roof Light	
Bulb	

AREA	
AREA WITHIN BOUNDARY WALL	159448.927 Sft
AREA OF CLINICAL BLOCK	34202.314 Sft
PLINTH AREA OF BLOCK	34202.314 Sft

OPENING SCHEDULE OF DOORS AND WINDOWS					
DOORS	WIDTH	HEIGHT	WINDOWS	WIDTH	HEIGHT
D1	5'-0"	7'-0"	W1	6'-0"	6'-0"
D2	3'-6"	7'-0"	W2	5'-0"	5'-0"
D3	2'-6"	7'-0"	W3	3'-0"	3'-0"
D4			W4	2'-0"	2'-0"
D5			W5	8'-0"	8'-0"
D6					
D7					
D8					
D9					

Project:
**CAD MAPPING OF TEHSIL
HEAD QUARTER HOSPITALS,
PUNJAB**

Client: GOVERNMENT OF THE PUNJAB PRIMARY & SECONDARY HEALTHCARE DEPARTMENT	Consultant: SKAFS CONSULTANT (Pvt.) Limited ENGINEERING AND ENVIRONMENT CONSULTANT
---	--


Drawing Title:
**THQ SHAKARGARH
HOSPITAL CLINICAL BLOCK PLAN**

Drawing No.
SKAFS/SHAKARGARH/08

CLINICAL BLOCK OF THQ HOSPITAL SHAKARGARH

GROUND FLOOR PART 1

PRODUCED BY AN AUTODESK EDUCATIONAL PRODUCT

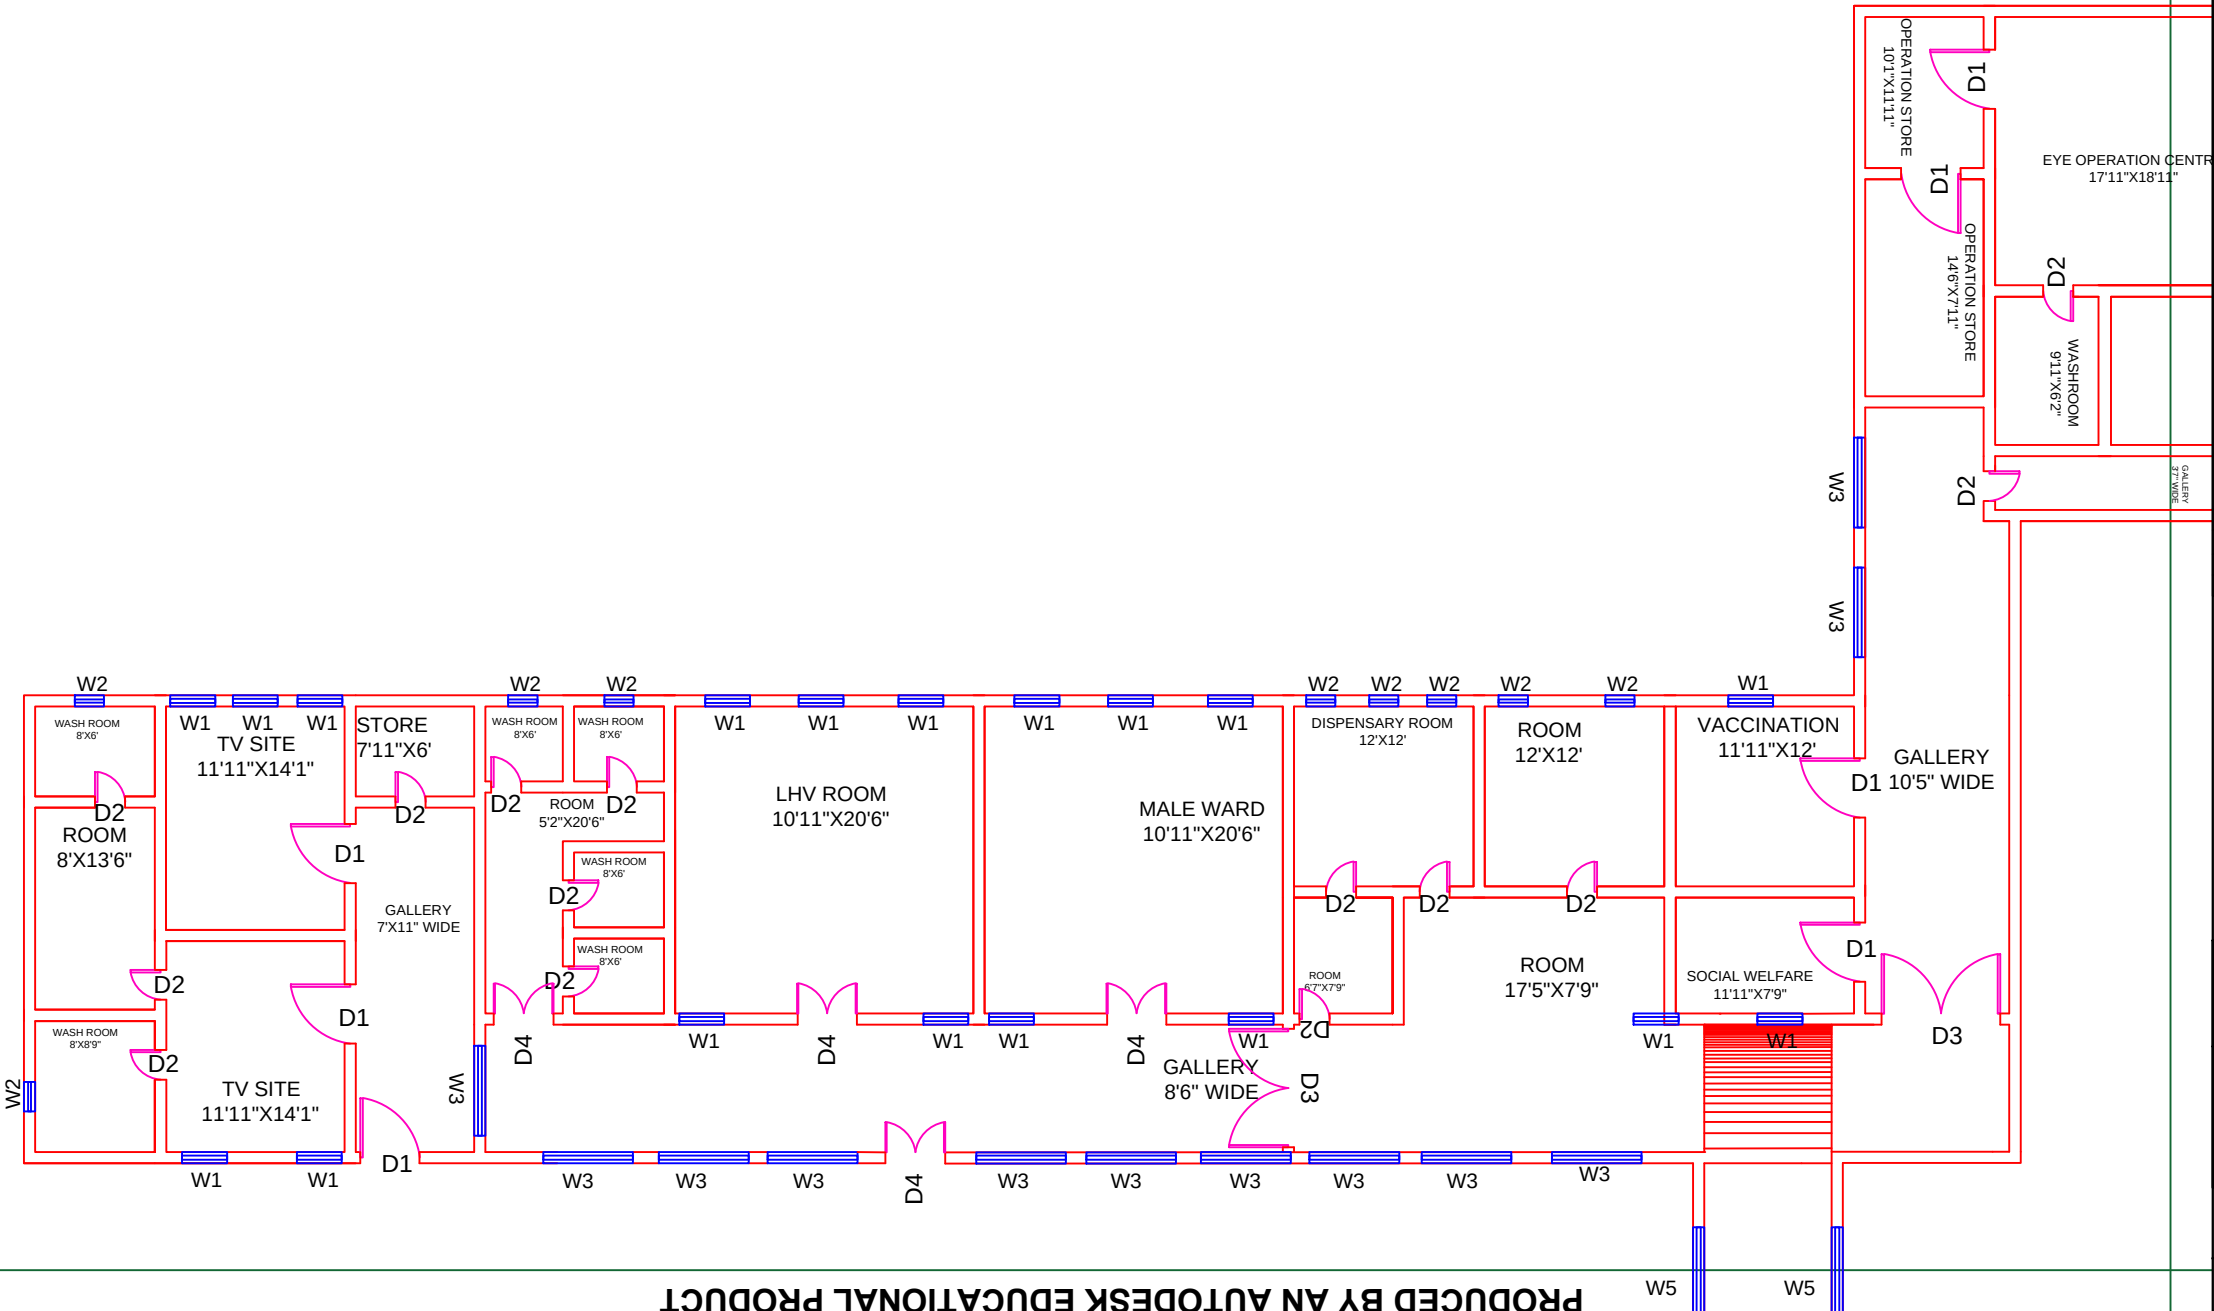

Legends:

Residential Area	
Road	
Wall	
Power Line	
OHT	
Tree	
Man Hole	
Tube Well	
Light Pole	
Lawns	
Earthen Areas	
Asphalts Roads	
Tough Pavers	
P.C.C / Plinth Protection	
Boundary Wall	
Brick Pavers / Soling	
Drain	
Tap	
Hand Pump	
Air Conditioner	
Tube Light	
Fan	
Roof Light	
Bulb	

AREA

AREA WITHIN BOUNDARY WALL	159448.927 Sft
AREA OF CLINICAL BLOCK	34202.314 Sft
PLINTH AREA OF BLOCK	34202.314 Sft

OPENING SCHEDULE OF DOORS AND WINDOWS

DOORS	WIDTH	HEIGHT	WINDOWS	WIDTH	HEIGHT
D1	5'-0"	7'-0"	W1	6'-0"	6'-0"
D2	3'-6"	7'-0"	W2	5'-0"	5'-0"
D3	2'-6"	7'-0"	W3	3'-0"	3'-0"
D4			W4	2'-0"	2'-0"
D5			W5	8'-0"	8'-0"
D6					
D7					
D8					
D9					

Project:
**CAD MAPPING OF TEHSIL
HEAD QUARTER HOSPITALS,
PUNJAB**

Client:

GOVERNMENT OF THE PUNJAB
PRIMARY & SECONDARY
HEALTHCARE DEPARTMENT

Consultant:

SKAFS CONSULTANT (Pvt.)
Limited
ENGINEERING AND ENVIRONMENT
CONSULTANT

Drawing Title:
**THQ SHAKARGARH
CLINICAL BLOCK PLAN (PART 1)**


Drawing No.
SKAFS/SHAKARGARH/09

PRODUCED BY AN AUTODESK EDUCATIONAL PRODUCT

CLINICAL BLOCK OF THQ HOSPITAL SHAKARGARH

GROUND FLOOR PART 2

PRODUCED BY AN AUTODESK EDUCATIONAL PRODUCT

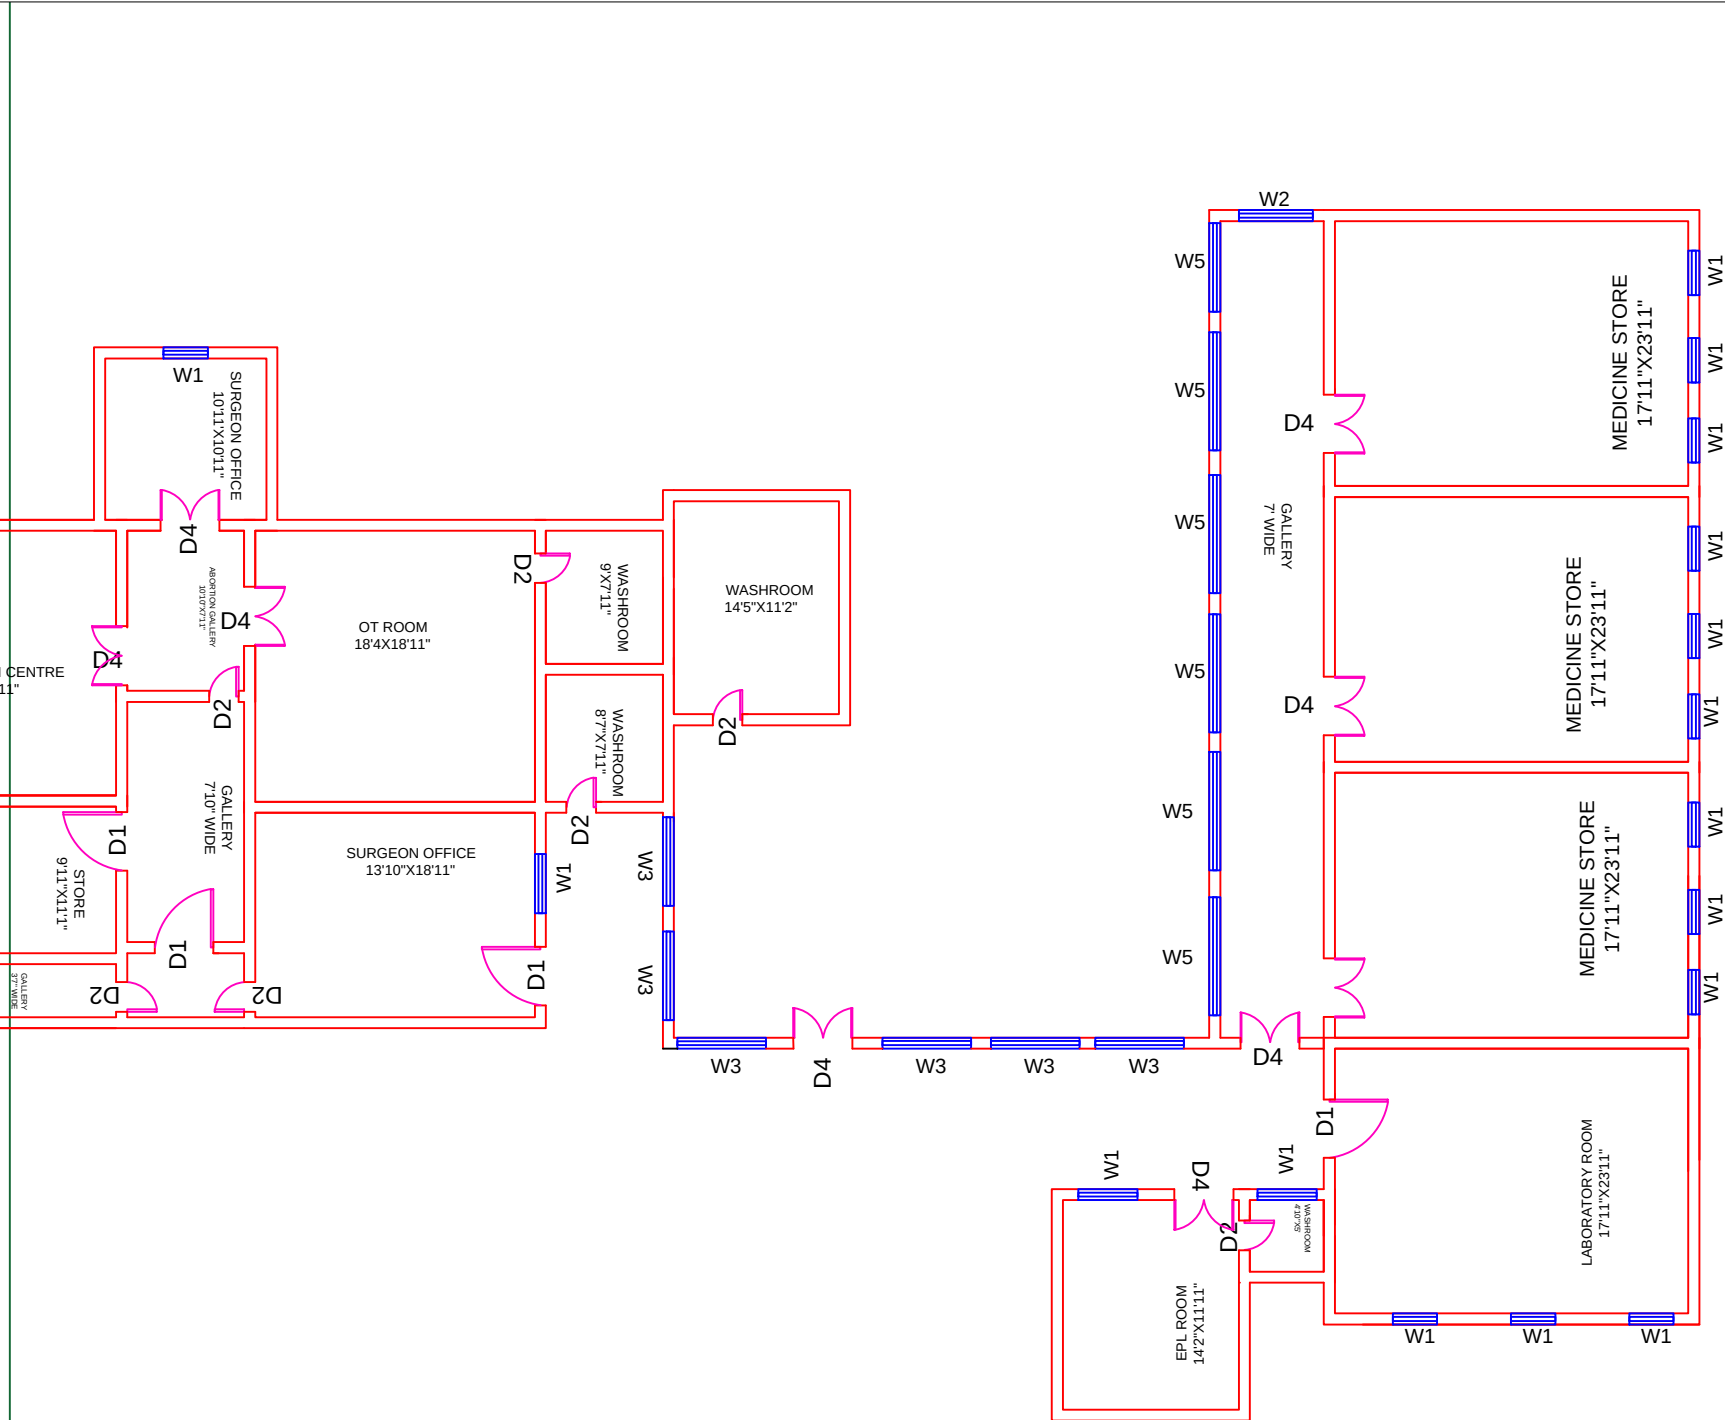

PRODUCED BY AN AUTODESK EDUCATIONAL PRODUCT

Legends:

Residential Area	
Road	
Wall	
Power Line	
OHT	
Tree	
Man Hole	
Tube Well	
Light Pole	
Lawns	
Earthen Areas	
Asphalts Roads	
Tough Pavers	
P.C.C / Plinth Protection	
Boundary Wall	
Brick Pavers / Soling	
Drain	
Tap	
Hand Pump	
Air Conditioner	
Tube Light	
Fan	
Roof Light	
Bulb	

AREA

AREA WITHIN BOUNDARY WALL	159448.927 Sft
AREA OF CLINICAL BLOCK	34202.314 Sft
PLINTH AREA OF BLOCK	34202.314 Sft

OPENING SCHEDULE OF DOORS AND WINDOWS

DOORS	WIDTH	HEIGHT	WINDOWS	WIDTH	HEIGHT
D1	5'-0"	7'-0"	W1	6'-0"	6'-0"
D2	3'-6"	7'-0"	W2	5'-0"	5'-0"
D3	2'-6"	7'-0"	W3	3'-0"	3'-0"
D4			W4	2'-0"	2'-0"
D5			W5	8'-0"	8'-0"
D6					
D7					
D8					
D9					

Project:
**CAD MAPPING OF TEHSIL
HEAD QUARTER HOSPITALS,
PUNJAB**

Client:

GOVERNMENT OF THE PUNJAB
PRIMARY & SECONDARY
HEALTHCARE DEPARTMENT

Consultant:

SKAFS CONSULTANT (Pvt.)
Limited
ENGINEERING AND ENVIRONMENT
CONSULTANT

Drawing Title:
**THQ SHAKARGARH
CLINICAL BLOCK PLAN (PART 2)**


Drawing No.
SKAFS/SHAKARGARH/10

PRODUCED BY AN AUTODESK EDUCATIONAL PRODUCT

CLINICAL BLOCK OF THQ HOSPITAL SHAKARGARH

GROUND FLOOR PART 3

PRODUCED BY AN AUTODESK EDUCATIONAL PRODUCT

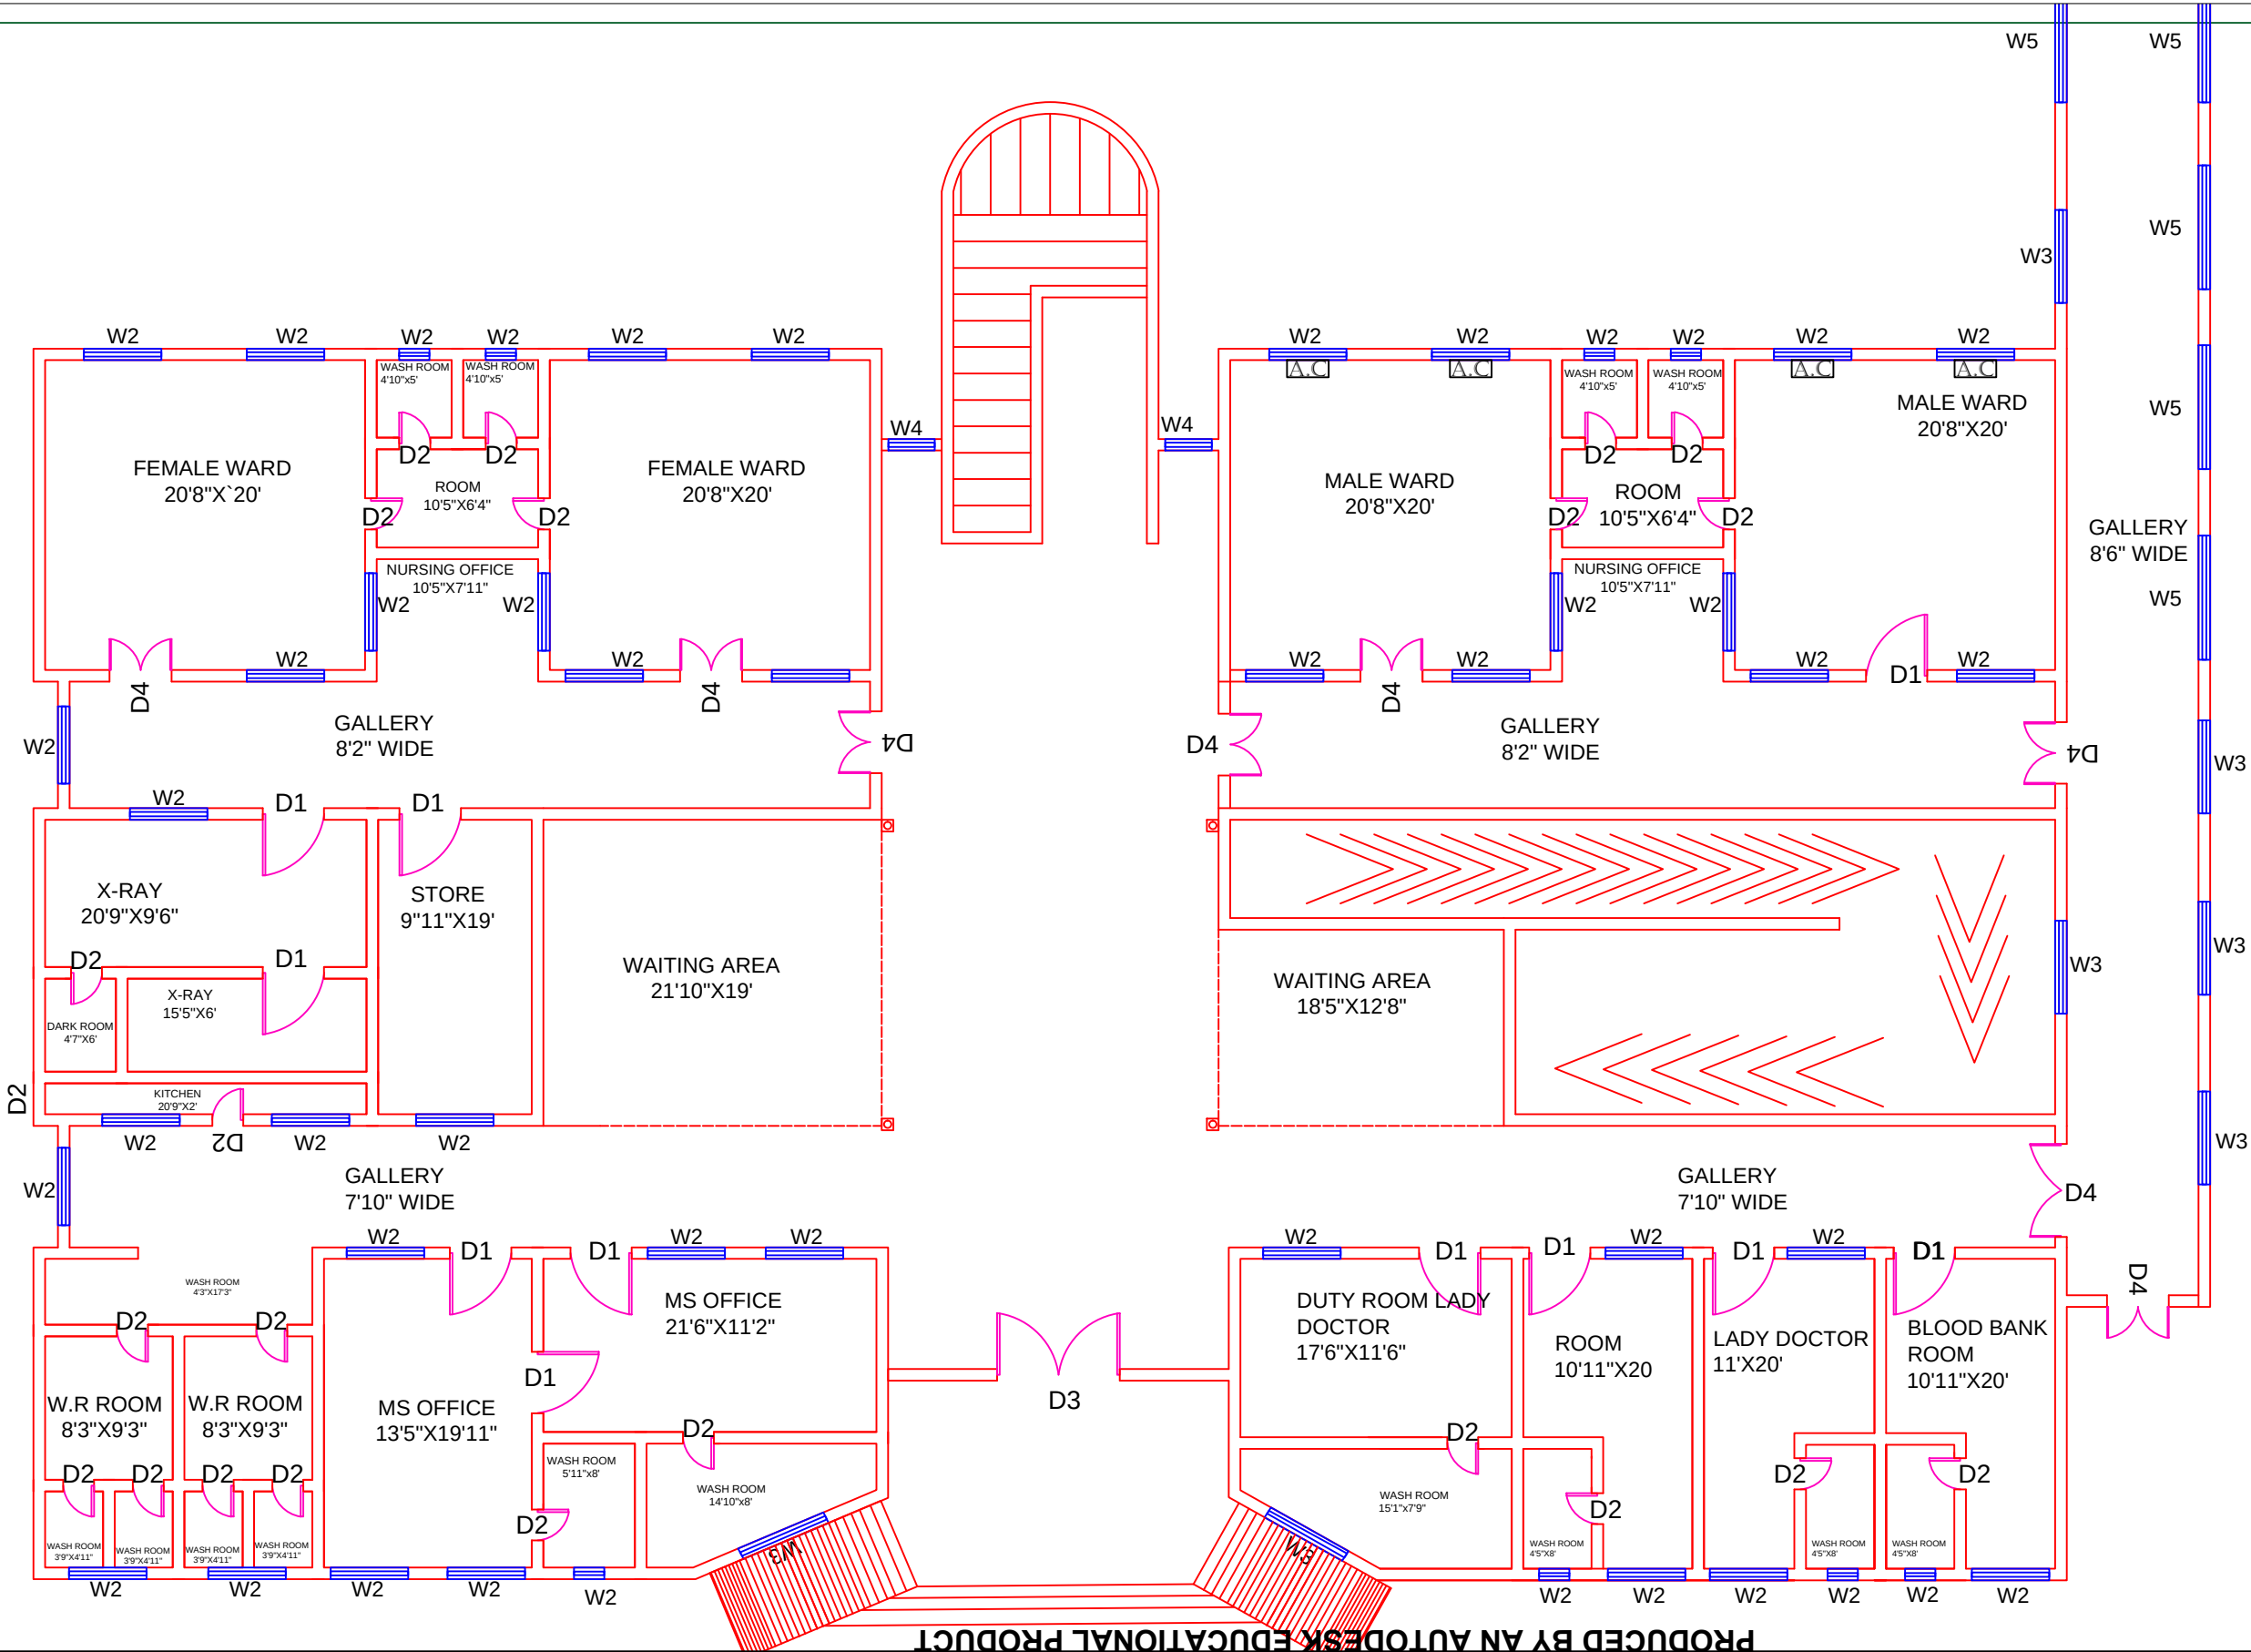

Legends:

Residential Area	
Road	
Wall	
Power Line	
OHT	
Tree	
Man Hole	
Tube Well	
Light Pole	
Lawns	
Earthen Areas	
Asphalts Roads	
Tough Pavers	
P.C.C / Plinth Protection	
Boundary Wall	
Brick Pavers / Soling	
Drain	
Tap	
Hand Pump	
Air Conditioner	
Tube Light	
Fan	
Roof Light	
Bulb	

AREA	
AREA WITHIN BOUNDARY WALL	159448.927 Sft
AREA OF CLINICAL BLOCK	34202.314 Sft
PLINTH AREA OF BLOCK	34202.314 Sft

OPENING SCHEDULE OF DOORS AND WINDOWS					
DOORS	WIDTH	HEIGHT	WINDOWS	WIDTH	HEIGHT
D1	5'-0"	7'-0"	W1	6'-0"	6'-0"
D2	3'-6"	7'-0"	W2	5'-0"	5'-0"
D3	2'-6"	7'-0"	W3	3'-0"	3'-0"
D4			W4	2'-0"	2'-0"
D5			W5	8'-0"	8'-0"
D6					
D7					
D8					
D9					

Project:
**CAD MAPPING OF TEHSIL
HEAD QUARTER HOSPITALS,
PUNJAB**

Client: GOVERNMENT OF THE PUNJAB PRIMARY & SECONDARY HEALTHCARE DEPARTMENT	Consultant: SKAFS CONSULTANT (Pvt.) Limited ENGINEERING AND ENVIRONMENT CONSULTANT
---	--

Drawing Title:
**THQ SHAKARGARH
CLINICAL BLOCK PLAN (PART 3)**


Drawing No.
SKAFS/SHAKARGARH/11

PRODUCED BY AN AUTODESK EDUCATIONAL PRODUCT

CLINICAL BLOCK OF THQ HOSPITAL SHAKARGARH

GROUND FLOOR PART 4

PRODUCED BY AN AUTODESK EDUCATIONAL PRODUCT

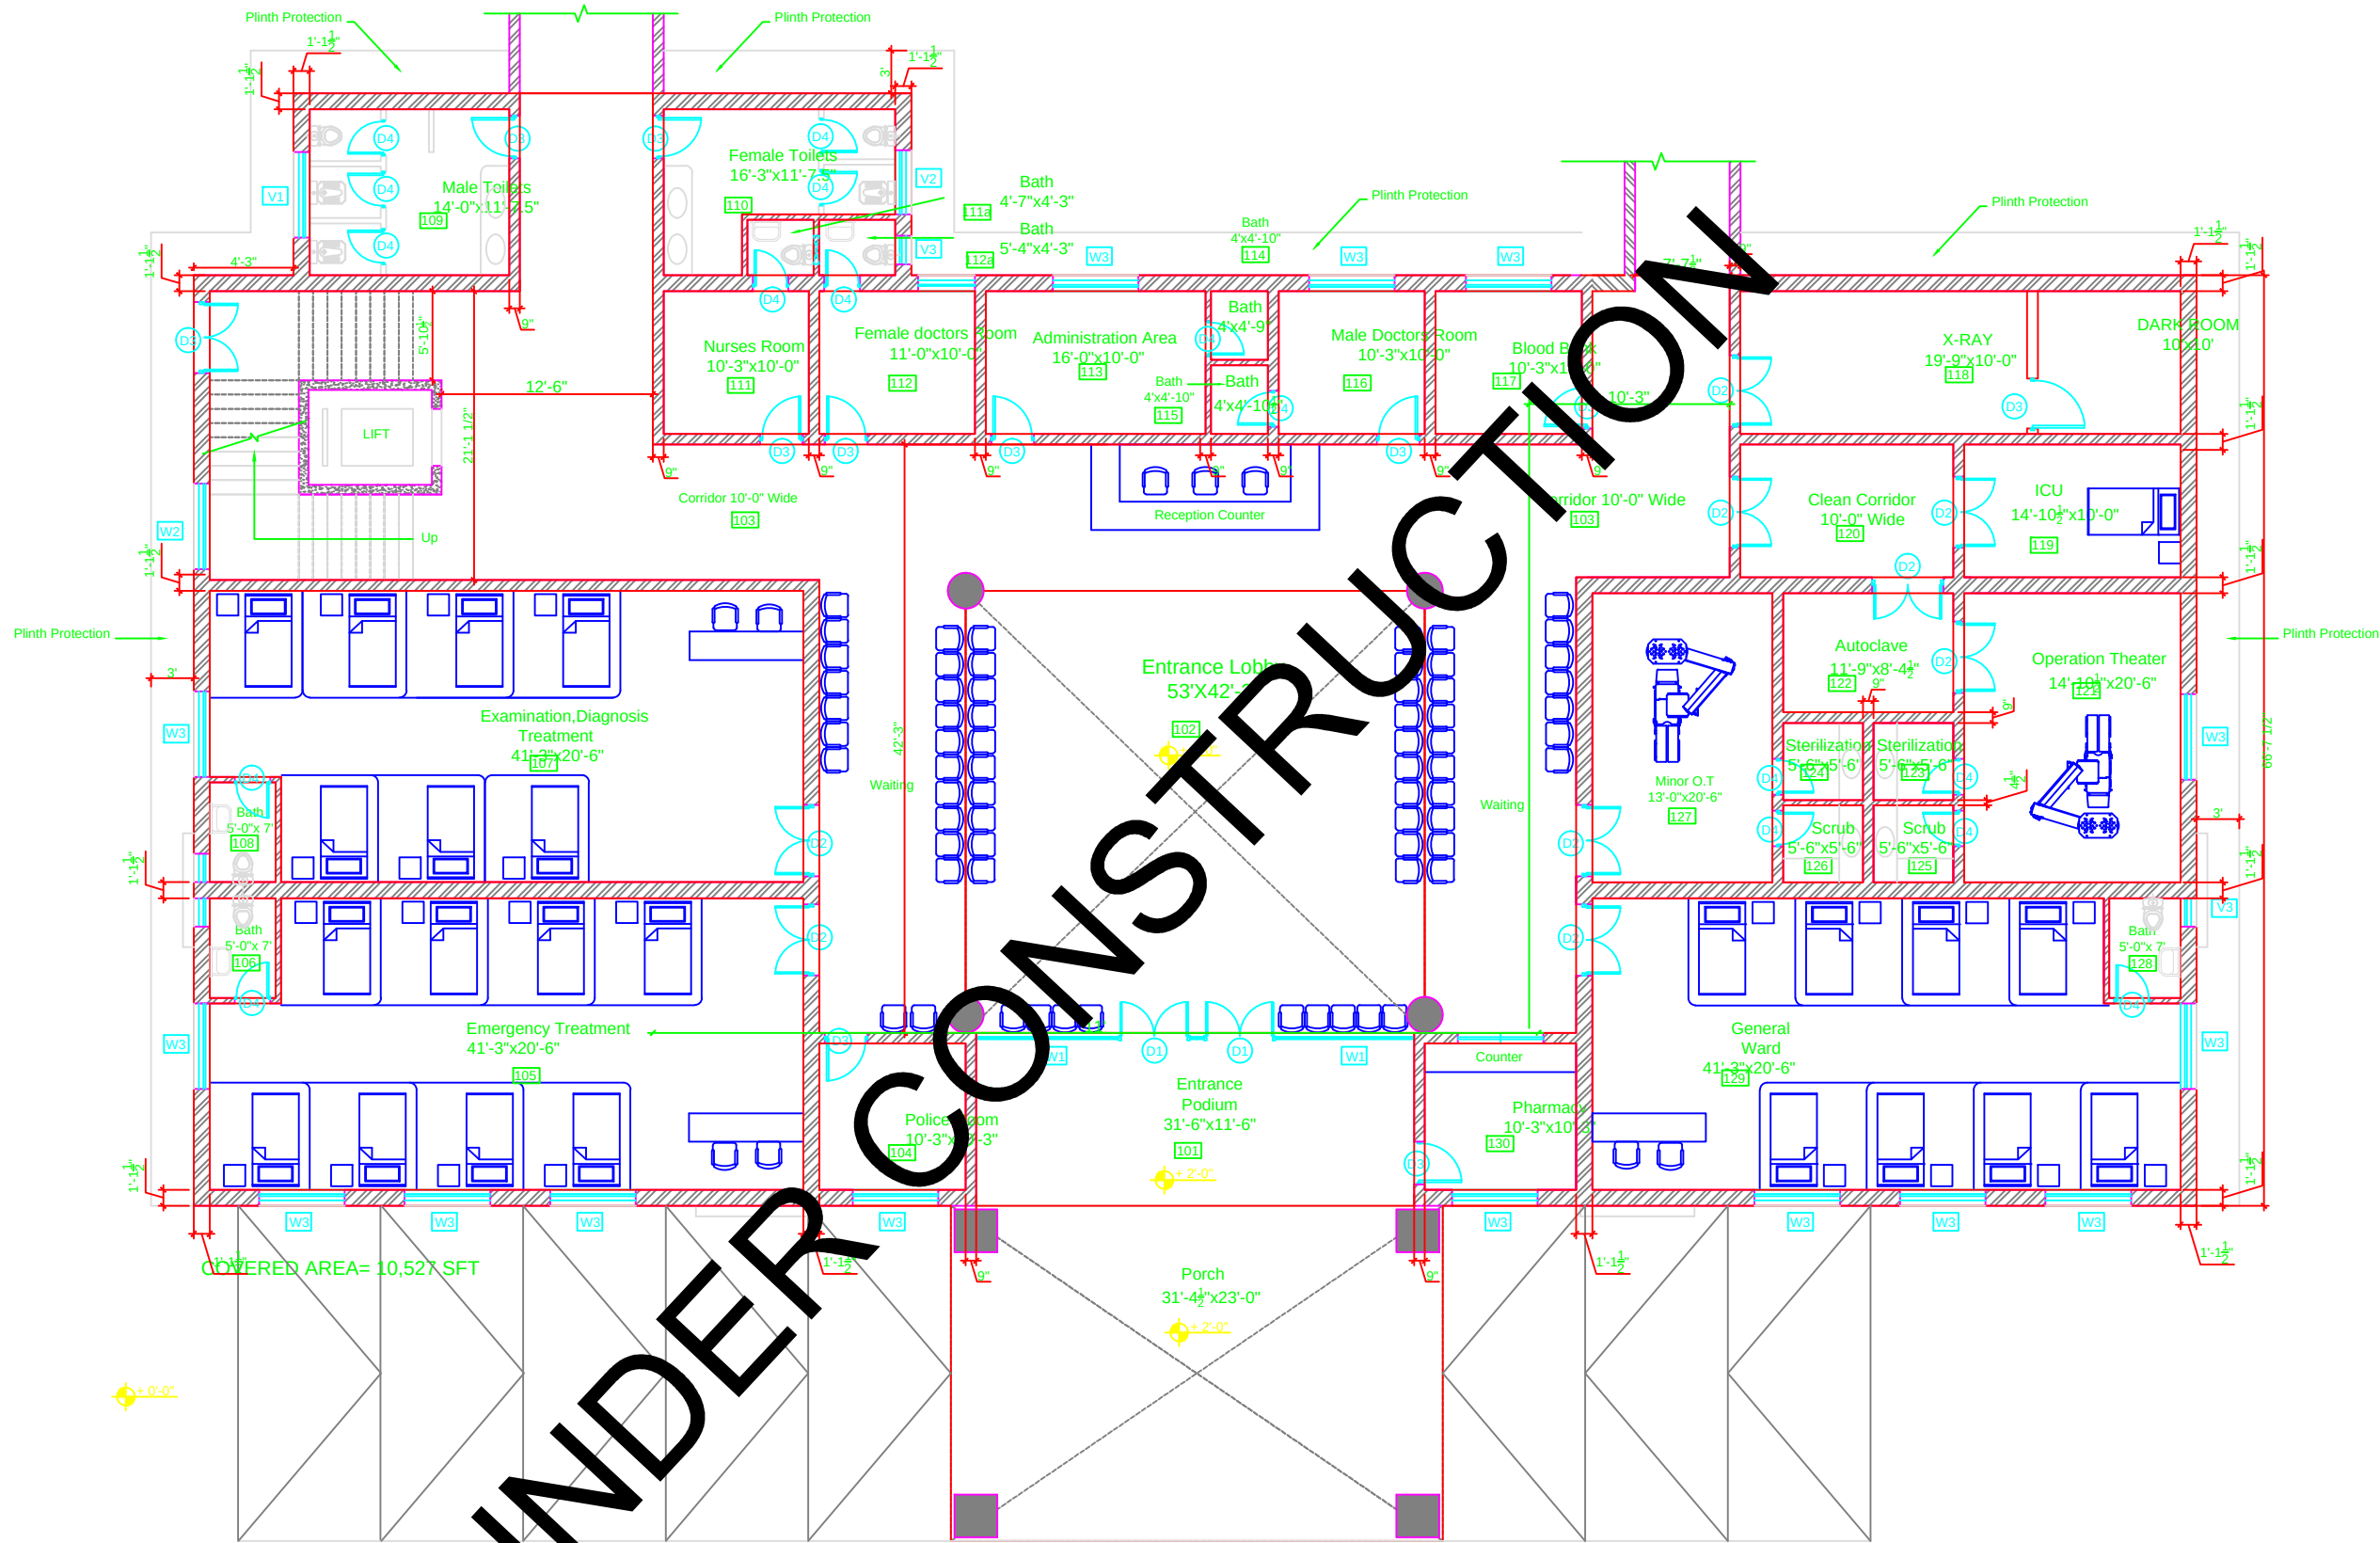

Legends:

Residential Area	
Road	
Wall	
Power Line	
OHT	
Tree	
Man Hole	
Tube Well	
Light Pole	
Lawns	
Earthen Areas	
Asphalts Roads	
Tough Pavers	
P.C.C / Plinth Protection	
Boundary Wall	
Brick Pavers / Soling	
Drain	
Tap	
Hand Pump	
Air Conditioner	
Tube Light	
Fan	
Roof Light	
Bulb	

AREA	
AREA WITHIN BOUNDARY WALL	159448.927 Sft
AREA OF CLINICAL BLOCK	34202.314 Sft
PLINTH AREA OF BLOCK	34202.314 Sft

OPENING SCHEDULE OF DOORS AND WINDOWS					
DOORS	WIDTH	HEIGHT	WINDOWS	WIDTH	HEIGHT
D1	5'-0"	7'-0"	W1	6'-0"	6'-0"
D2	3'-6"	7'-0"	W2	5'-0"	5'-0"
D3	2'-6"	7'-0"	W3	3'-0"	3'-0"
D4			W4	2'-0"	2'-0"
D5			W5	8'-0"	8'-0"
D6					
D7					
D8					
D9					

Project:
**CAD MAPPING OF TEHSIL
HEAD QUARTER HOSPITALS,
PUNJAB**

Client: GOVERNMENT OF THE PUNJAB PRIMARY & SECONDARY HEALTHCARE DEPARTMENT	Consultant: SKAFS CONSULTANT (Pvt.) Limited ENGINEERING AND ENVIRONMENT CONSULTANT
---	--


Drawing Title:
**THQ SHAKARGARH
CLINICAL BLOCK PLAN (PART 4)**

Drawing No.
SKAFS/SHAKARGARH/12

PRODUCED BY AN AUTODESK EDUCATIONAL PRODUCT

ELECTRICAL LAYOUT PLAN OF THQ HOSPITAL SHAKARGARH

GROUND FLOOR

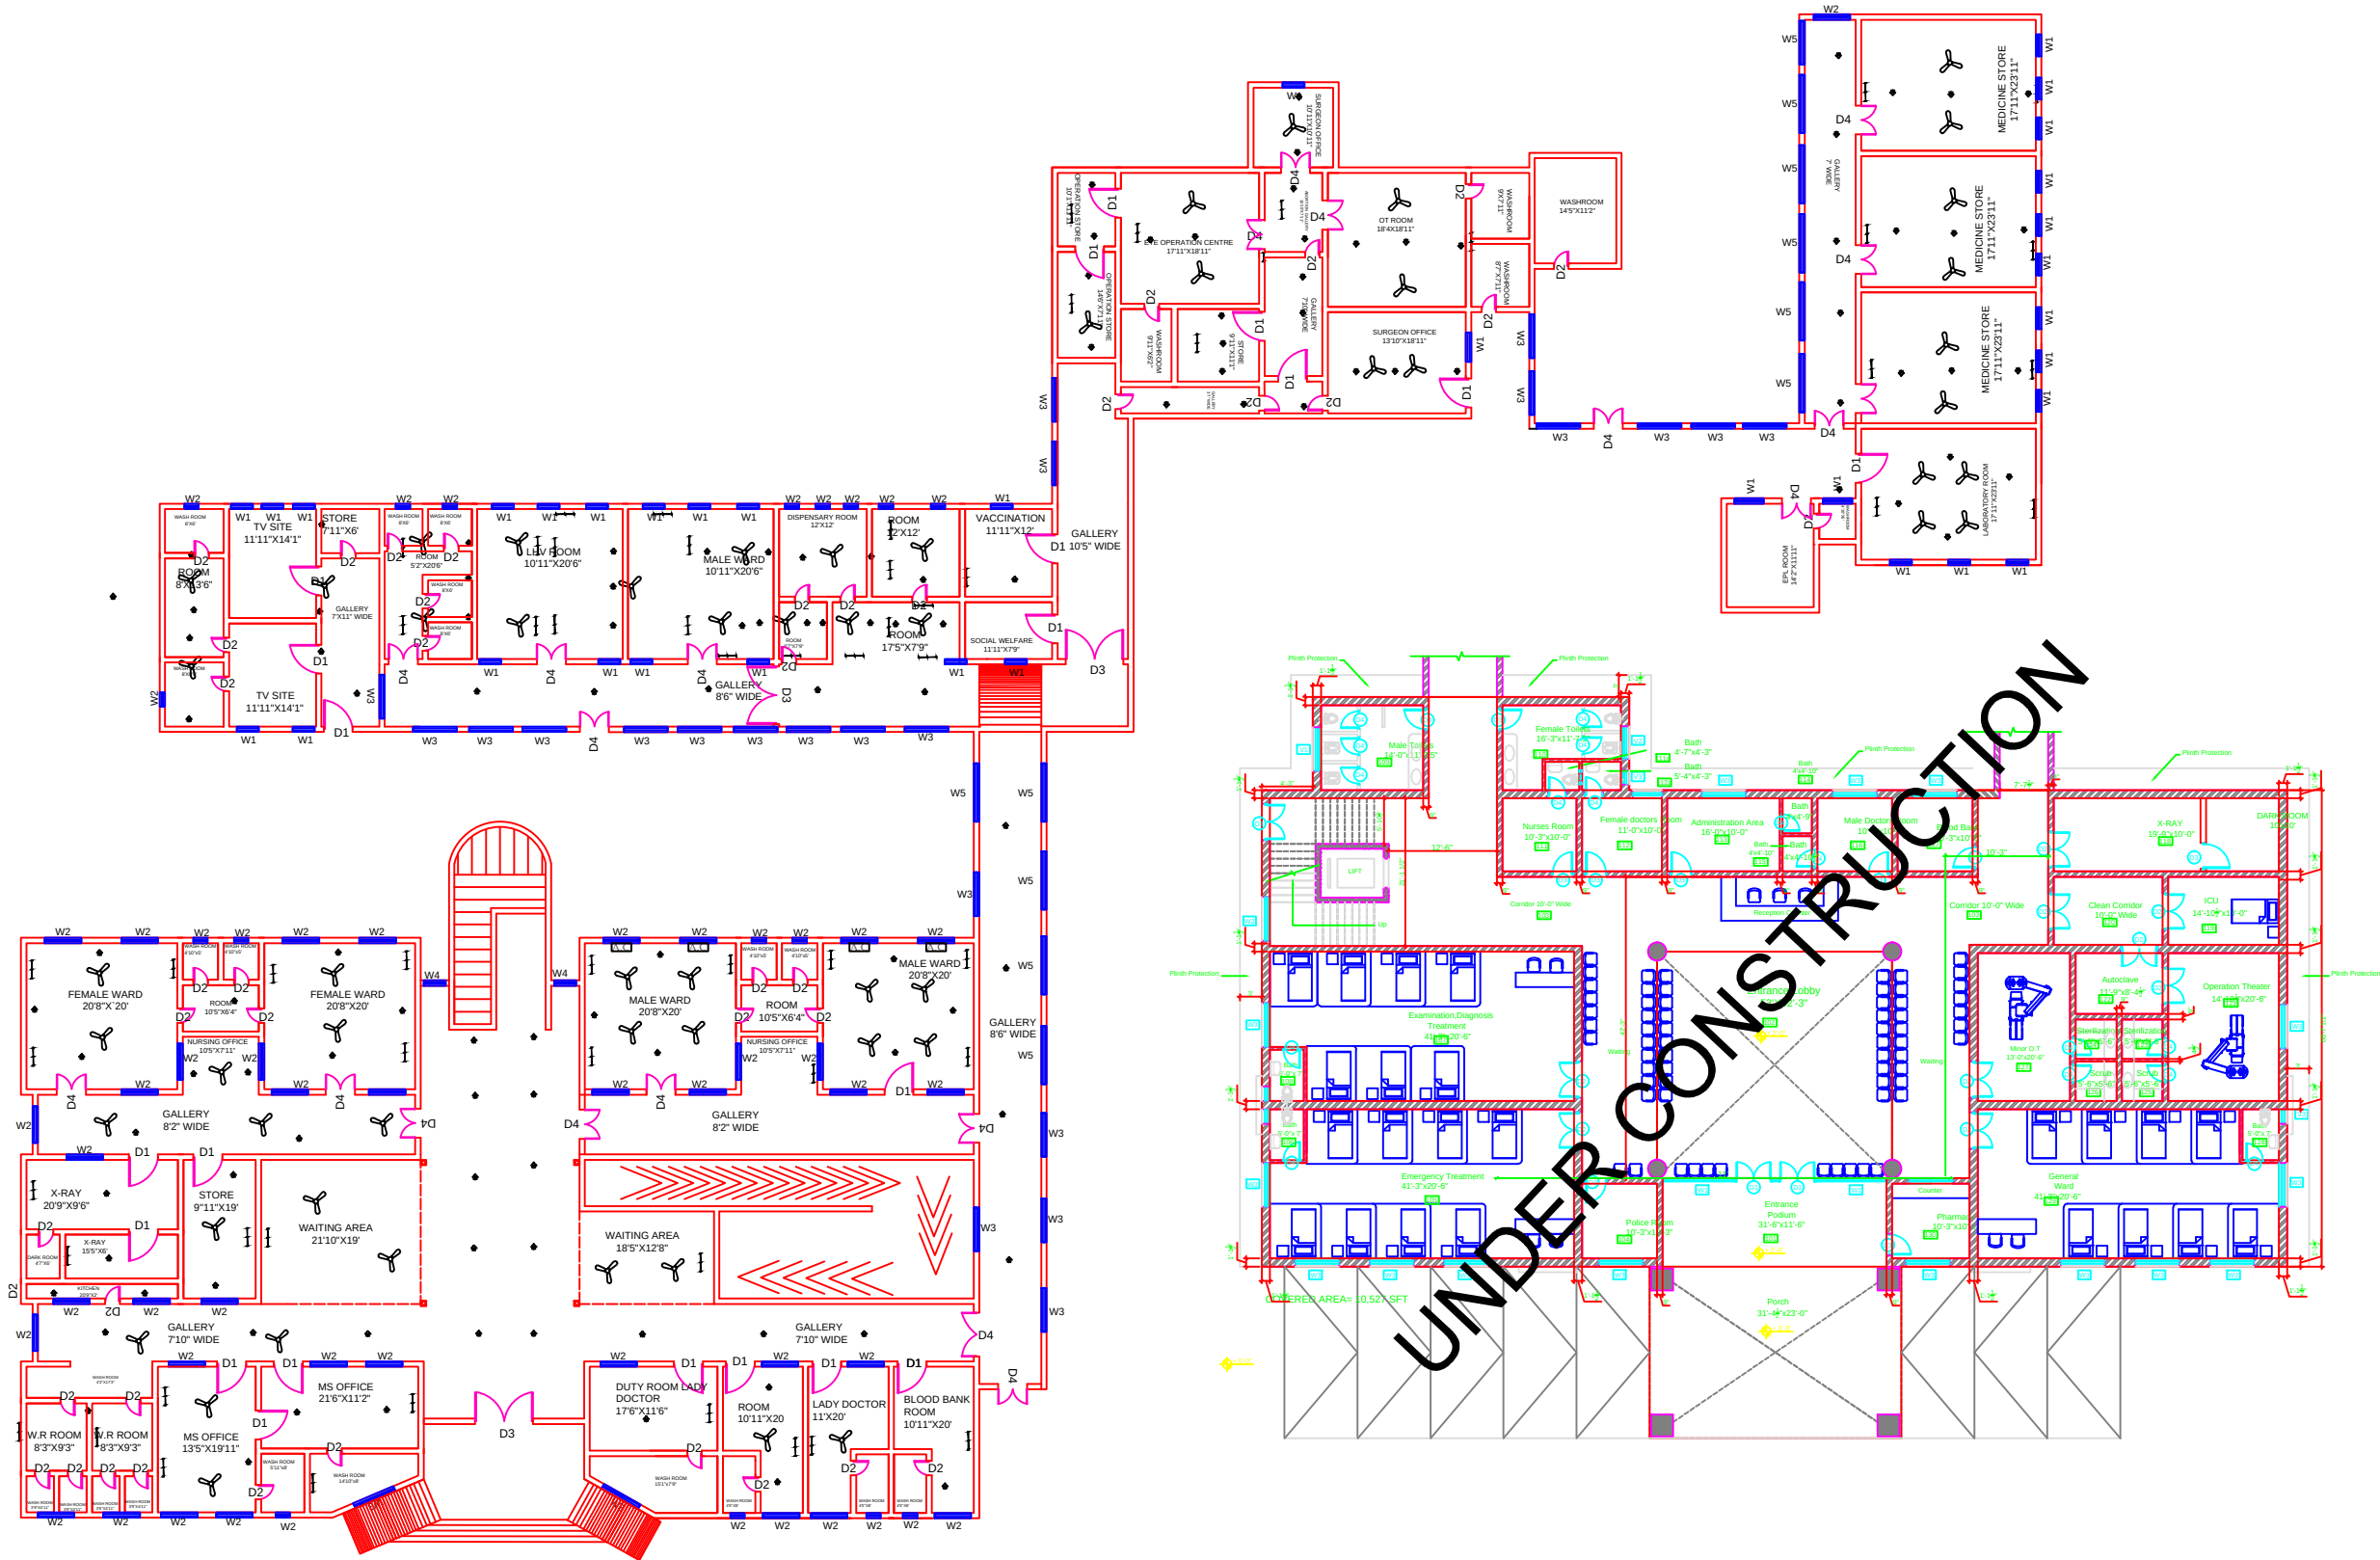

Legends:

Residential Area	
Road	
Wall	
Power Line	
OHT	
Tree	
Man Hole	
Tube Well	
Light Pole	
Lawns	
Earthen Areas	
Asphalts Roads	
Tough Pavers	
P.C.C / Plinth Protection	
Boundary Wall	
Brick Pavers / Soling	
Drain	
Tap	
Hand Pump	
Air Conditioner	
Tube Light	
Fan	
Roof Light	
Bulb	

AREA	
AREA WITHIN BOUNDARY WALL	159448.927 Sft
AREA OF CLINICAL BLOCK	34202.314 Sft
PLINTH AREA OF BLOCK	34202.314 Sft

OPENING SCHEDULE OF DOORS AND WINDOWS					
DOORS	WIDTH	HEIGHT	WINDOWS	WIDTH	HEIGHT
D1	5'-0"	7'-0"	W1	6'-0"	6'-0"
D2	3'-6"	7'-0"	W2	5'-0"	5'-0"
D3	2'-6"	7'-0"	W3	3'-0"	3'-0"
D4			W4	2'-0"	2'-0"
D5			W5	8'-0"	8'-0"
D6					
D7					
D8					
D9					

Project:
**CAD MAPPING OF TEHSIL
HEAD QUARTER HOSPITALS,
PUNJAB**

Client: GOVERNMENT OF THE PUNJAB PRIMARY & SECONDARY HEALTHCARE DEPARTMENT	Consultant: SKAFS CONSULTANT (Pvt.) Limited ENGINEERING AND ENVIRONMENT CONSULTANT
---	--

Drawing Title:
**THQ SHAKARGARH
ELECTRICAL PLAN (GROUND FLOOR)**

Drawing No.
SKAFS/SHAKARGARH/13