


MASTER PLAN OF THQ HOSPITAL JAND

PART 1

PART 2

PART 3

PART 4

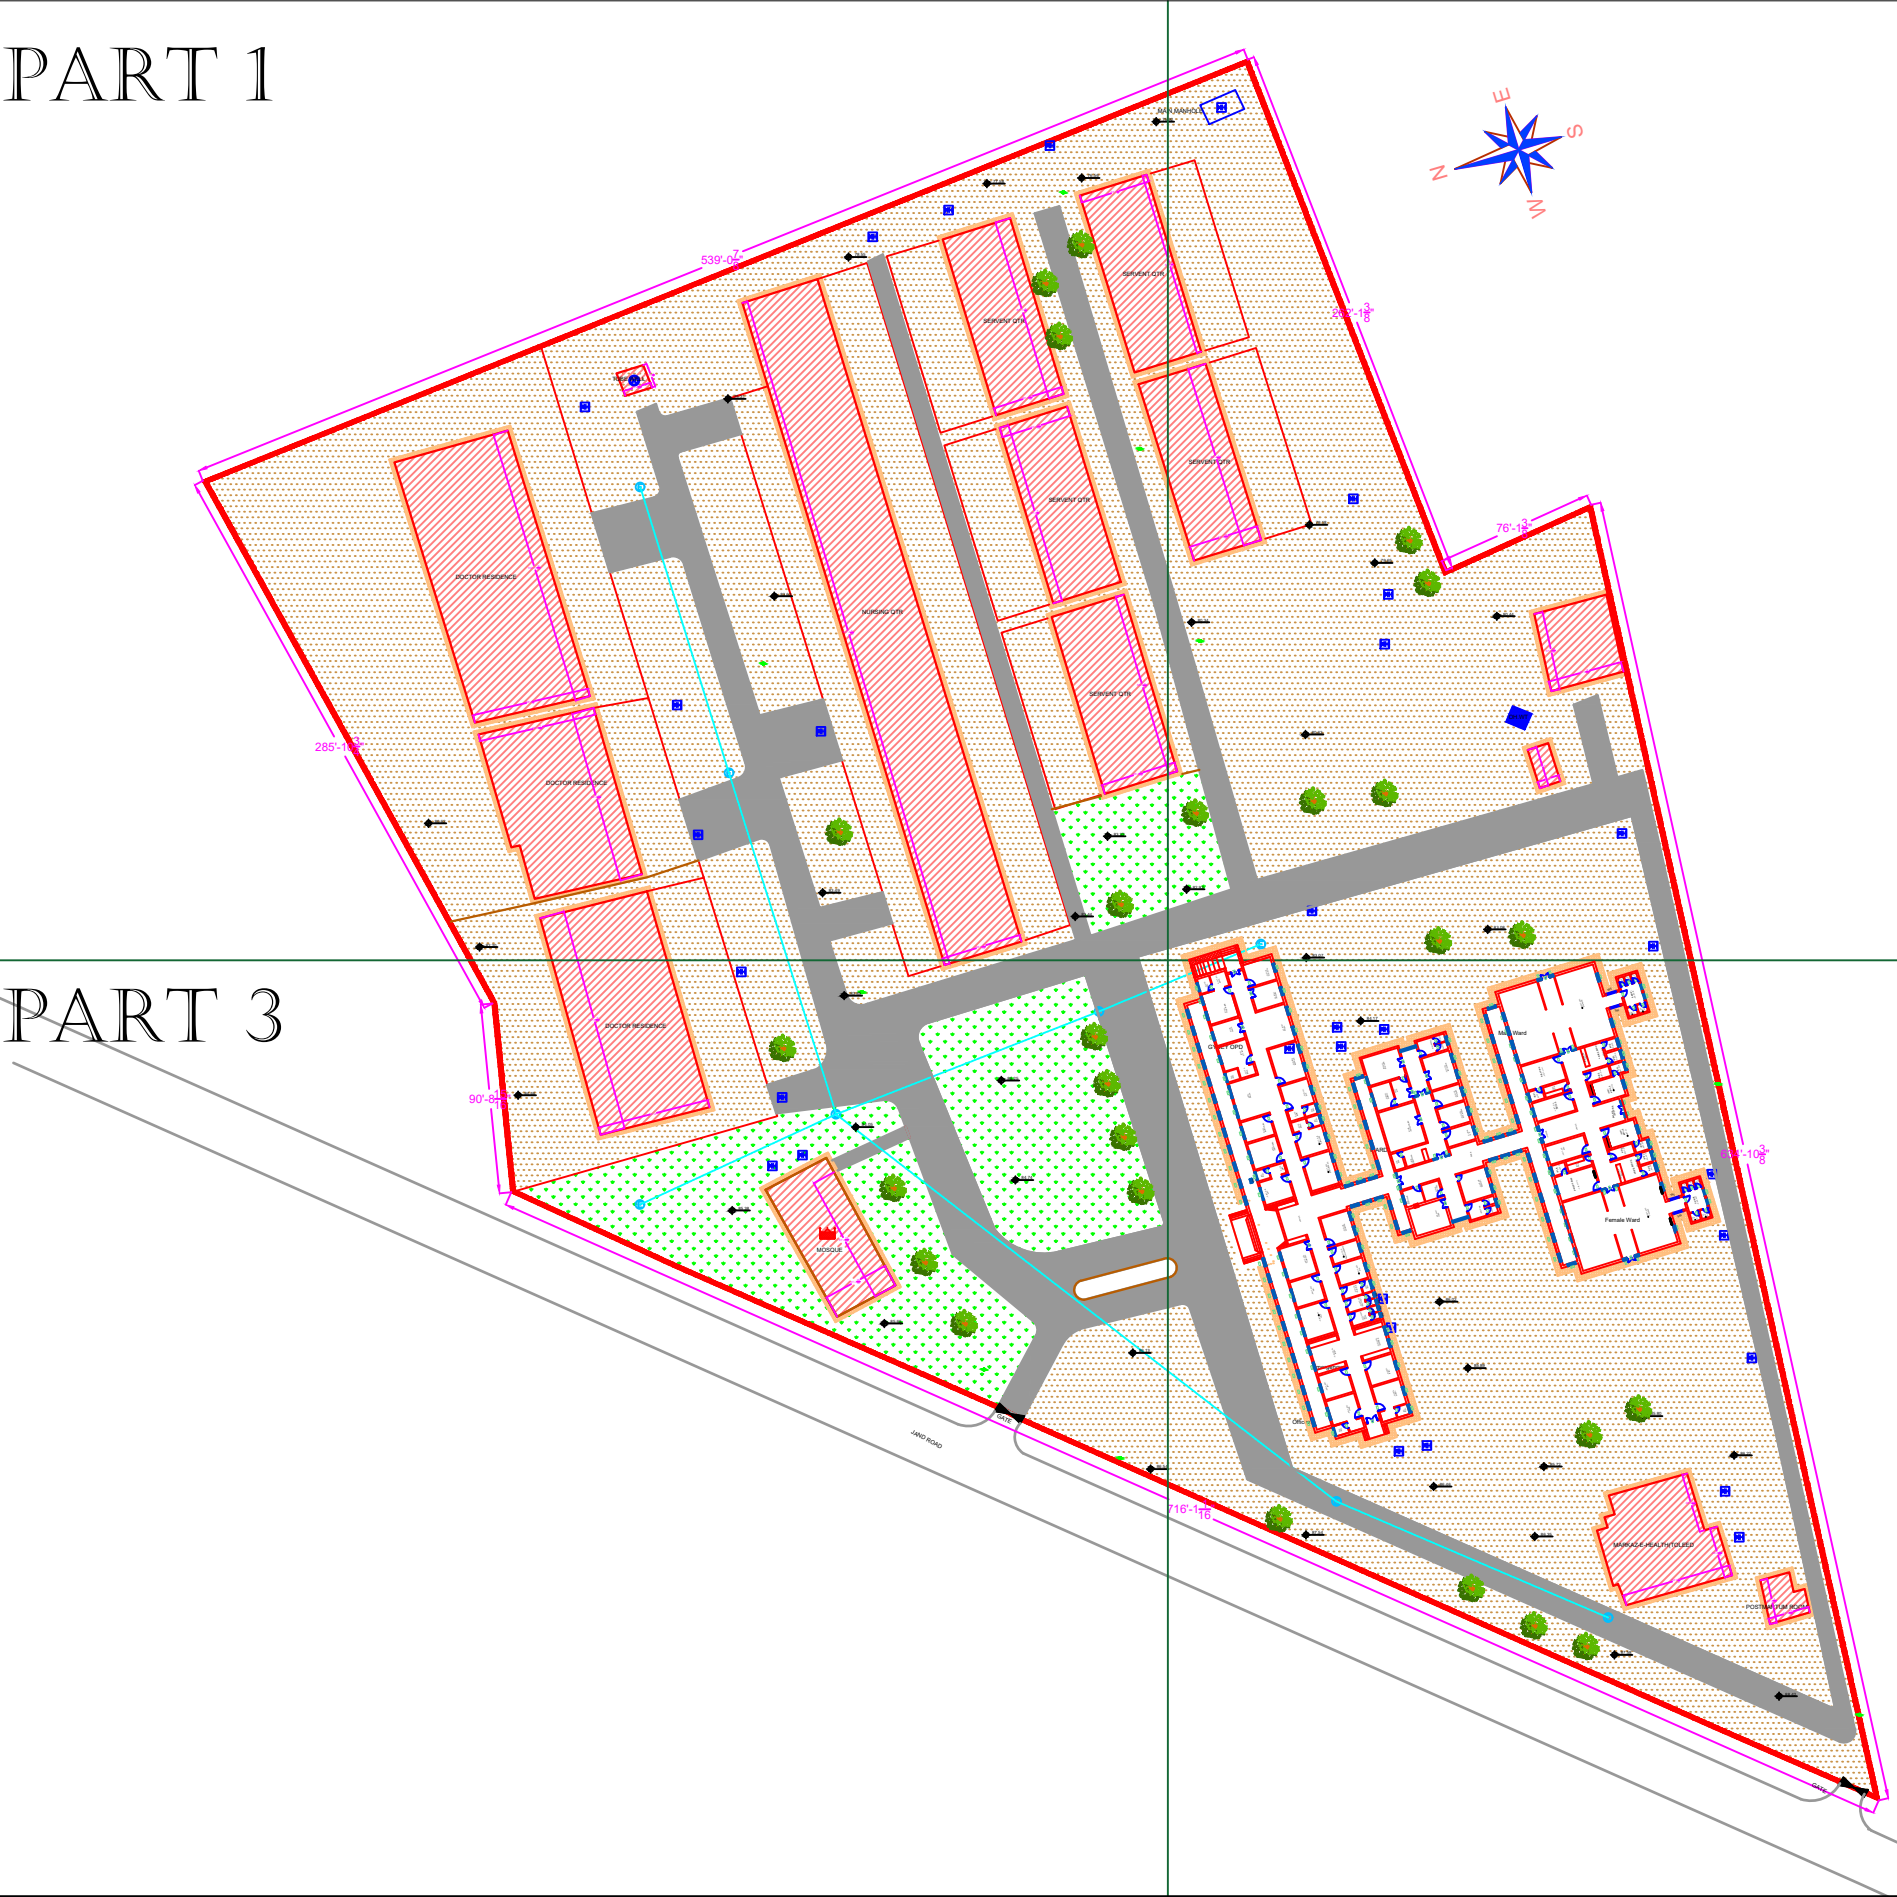


Legends:

Residential Area	
Road	
Wall	
Power Line	
OHT	
Tree	
Man Hole	
Tube Well	
Light Pole	
Lawns	
Earthen Areas	
Asphalts Roads	
Tough Pavers	
P.C.C / Plinth Protection	
Boundary Wall	
Brick Pavers / Soling	
Drain	
Tap	
Hand Pump	
Air Conditioner	
Tube Light	
Fan	
Roof Light	
Bulb	

AREA	
AREA WITHIN BOUNDARY WALL	350102.606 Sft
AREA OF CLINICAL BLOCK	24511.362 Sft
PLINTH AREA OF BLOCK	24511.362 Sft

OPENING SCHEDULE OF DOORS AND WINDOWS					
DOORS	WIDTH	HEIGHT	WINDOWS	WIDTH	HEIGHT
D1	5'-6"	7'-0"	W1	3'-0"	3'-0"
D2	5'-0"	7'-0"	W2	3'-6"	3'-6"
D3	4'-0"	7'-0"	W3	6'-0"	6'-0"
D4	3'-6"	7'-0"	W4	4'-6"	4'-6"
D5	3'-0"	7'-0"	W5	8'-6"	8'-6"
D6	2'-6"	7'-0"	W6	2'-6"	2'-6"
D7	6'-0"	7'-0"	W7	4'-0"	4'-0"
V1	1'-6"	1'-6"	W8	5'-0"	5'-0"
V2	2'-0"	2'-0"	W9	2'-0"	2'-0"

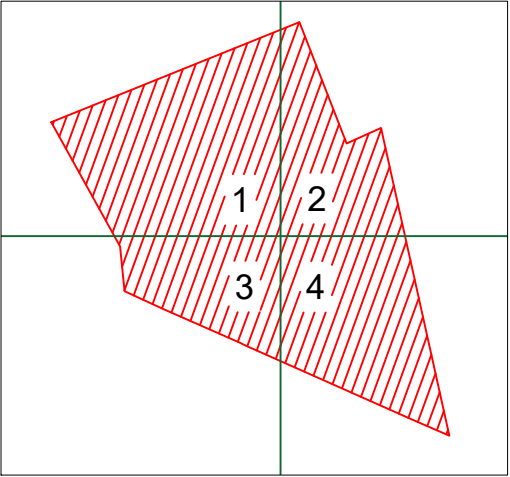

Project:
**CAD MAPPING OF TEHSIL
HEAD QUARTER HOSPITALS,
PUNJAB**



Client: GOVERNMENT OF THE PUNJAB PRIMARY & SECONDARY HEALTHCARE DEPARTMENT	Consultant: SKAFS CONSULTANT (Pvt.) Limited ENGINEERING AND ENVIRONMENT CONSULTANT
---	--

Drawing Title: **THQ JAND
HOSPITAL MASTER PLAN**

Drawing No. **SKAFS/JAND /03**

MASTER PLAN OF THQ HOSPITAL JAND

PART 1

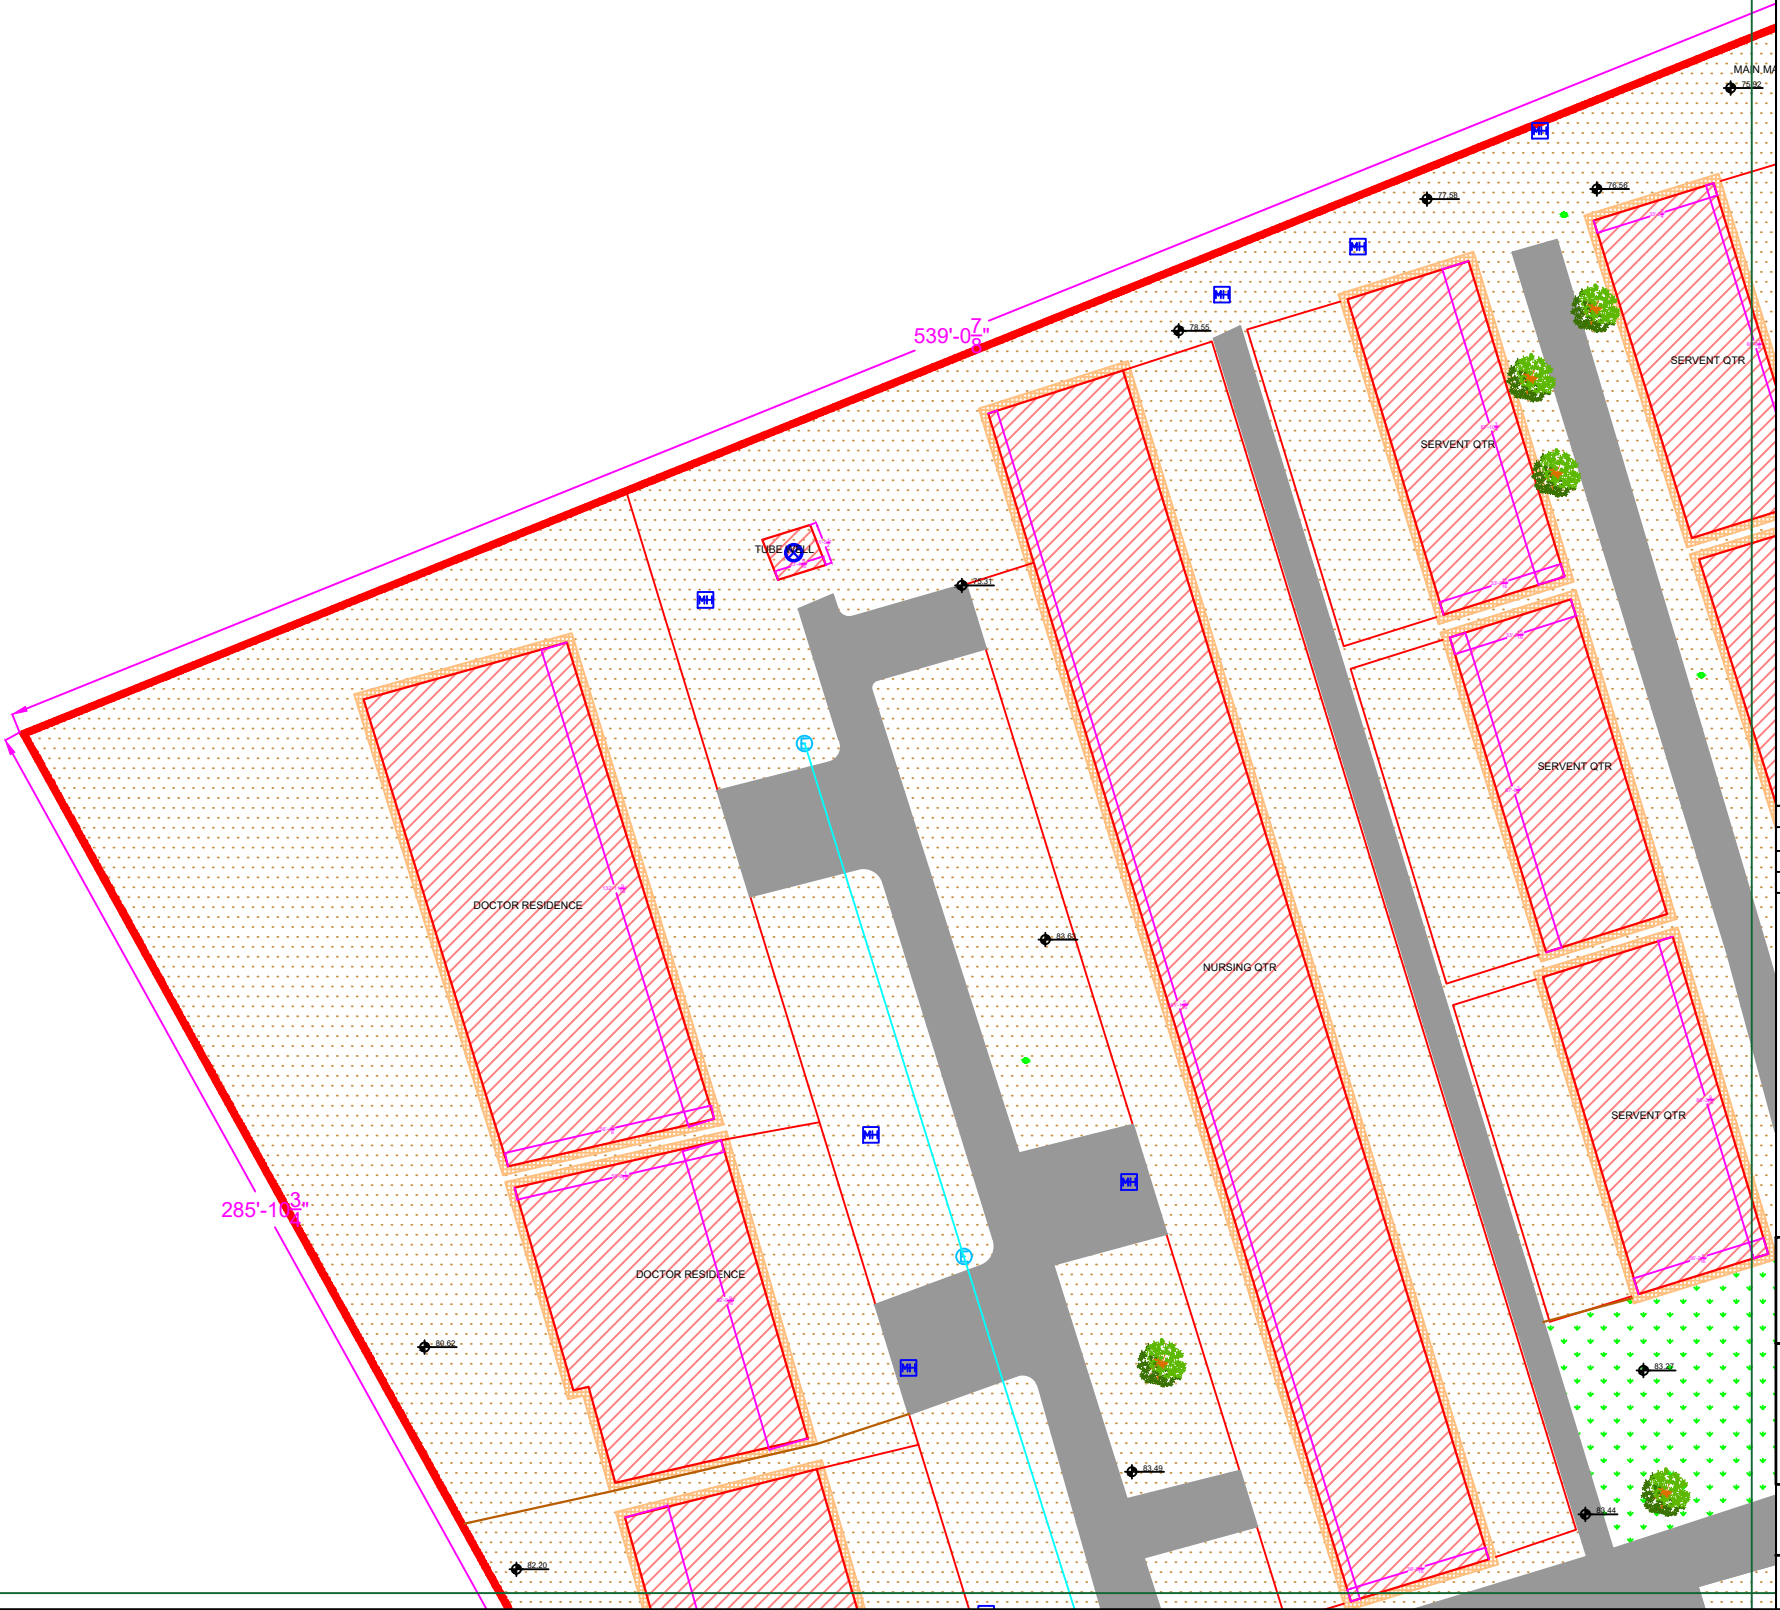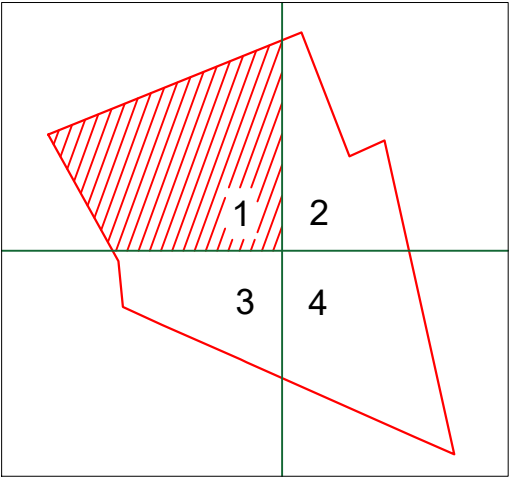

Legends:	
Residential Area	
Road	
Wall	
Power Line	
OHT	
Tree	
Man Hole	
Tube Well	
Light Pole	
Lawns	
Earthen Areas	
Asphalts Roads	
Tough Pavers	
P.C.C / Plinth Protection	
Boundary Wall	
Brick Pavers / Soling	
Drain	
Tap	
Hand Pump	
Air Conditioner	
Tube Light	
Fan	
Roof Light	
Bulb	

AREA	
AREA WITHIN BOUNDARY WALL	350102.606 Sft
AREA OF CLINICAL BLOCK	24511.362 Sft
PLINTH AREA OF BLOCK	24511.362 Sft

OPENING SCHEDULE OF DOORS AND WINDOWS					
DOORS	WIDTH	HEIGHT	WINDOWS	WIDTH	HEIGHT
D1	5'-6"	7'-0"	W1	3'-0"	3'-0"
D2	5'-0"	7'-0"	W2	3'-6"	3'-6"
D3	4'-0"	7'-0"	W3	6'-0"	6'-0"
D4	3'-6"	7'-0"	W4	4'-6"	4'-6"
D5	3'-0"	7'-0"	W5	8'-6"	8'-6"
D6	2'-6"	7'-0"	W6	2'-6"	2'-6"
D7	6'-0"	7'-0"	W7	4'-0"	4'-0"
V1	1'-6"	1'-6"	W8	5'-0"	5'-0"
V2	2'-0"	2'-0"	W9	2'-0"	2'-0"

Project:
**CAD MAPPING OF TEHSIL
HEAD QUARTER HOSPITALS,
PUNJAB**


Client: GOVERNMENT OF THE PUNJAB PRIMARY & SECONDARY HEALTHCARE DEPARTMENT	Consultant: SKAFS CONSULTANT (Pvt.) Limited ENGINEERING AND ENVIRONMENT CONSULTANT
---	--

Drawing Title:
**THQ JAND
HOSPITAL MASTER PLAN PART 1**

Drawing No.
SKAFS/JAND /04

MASTER PLAN OF THQ HOSPITAL JAND

PART 2

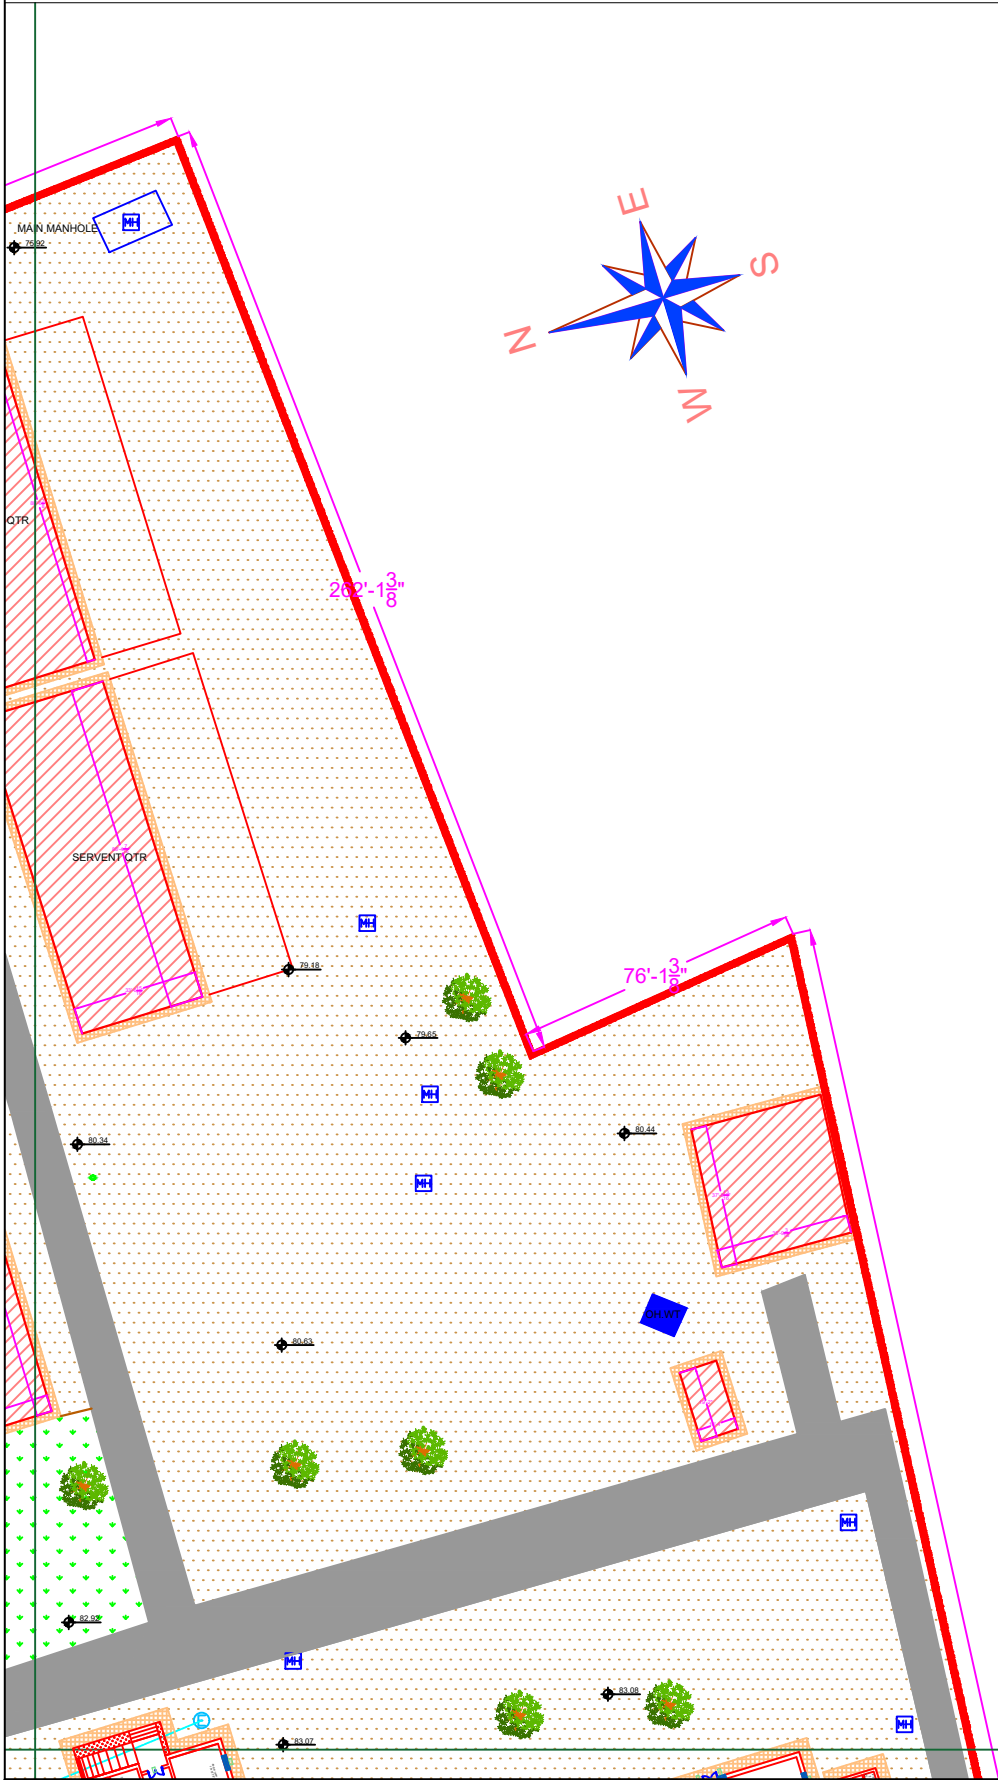

Legends:

Residential Area	
Road	
Wall	
Power Line	
OHT	
Tree	
Man Hole	
Tube Well	
Light Pole	
Lawns	
Earthen Areas	
Asphalts Roads	
Tough Pavers	
P.C.C / Plinth Protection	
Boundary Wall	
Brick Pavers / Soling	
Drain	
Tap	
Hand Pump	
Air Conditioner	
Tube Light	
Fan	
Roof Light	
Bulb	

AREA	
AREA WITHIN BOUNDARY WALL	350102.606 Sft
AREA OF CLINICAL BLOCK	24511.362 Sft
PLINTH AREA OF BLOCK	24511.362 Sft


OPENING SCHEDULE OF DOORS AND WINDOWS					
DOORS	WIDTH	HEIGHT	WINDOWS	WIDTH	HEIGHT
D1	5'-6"	7'-0"	W1	3'-0"	3'-0"
D2	5'-0"	7'-0"	W2	3'-6"	3'-6"
D3	4'-0"	7'-0"	W3	6'-0"	6'-0"
D4	3'-6"	7'-0"	W4	4'-6"	4'-6"
D5	3'-0"	7'-0"	W5	8'-6"	8'-6"
D6	2'-6"	7'-0"	W6	2'-6"	2'-6"
D7	6'-0"	7'-0"	W7	4'-0"	4'-0"
V1	1'-6"	1'-6"	W8	5'-0"	5'-0"
V2	2'-0"	2'-0"	W9	2'-0"	2'-0"

Project:
**CAD MAPPING OF TEHSIL
HEAD QUARTER HOSPITALS,
PUNJAB**

Client: GOVERNMENT OF THE PUNJAB PRIMARY & SECONDARY HEALTHCARE DEPARTMENT	Consultant: SKAFS CONSULTANT (Pvt.) Limited ENGINEERING AND ENVIRONMENT CONSULTANT
---	--



Drawing Title:
**THQ JAND
HOSPITAL MASTER PLAN PART 2**

Drawing No.
SKAFS/JAND /05

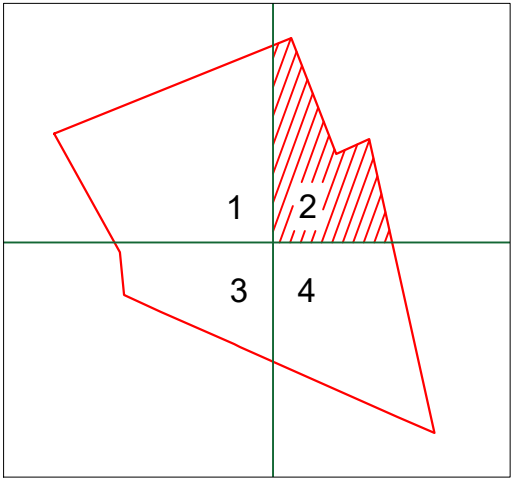

MASTER PLAN OF THQ HOSPITAL JAND

PART 3

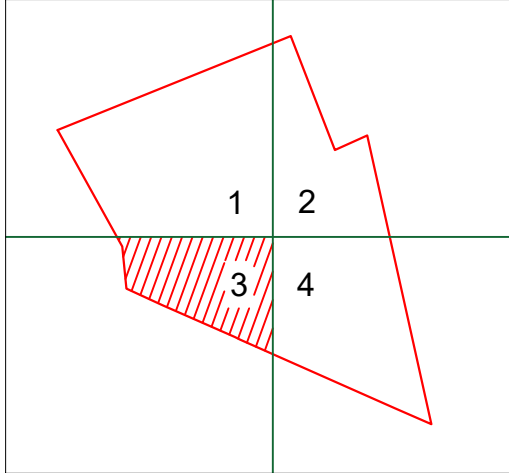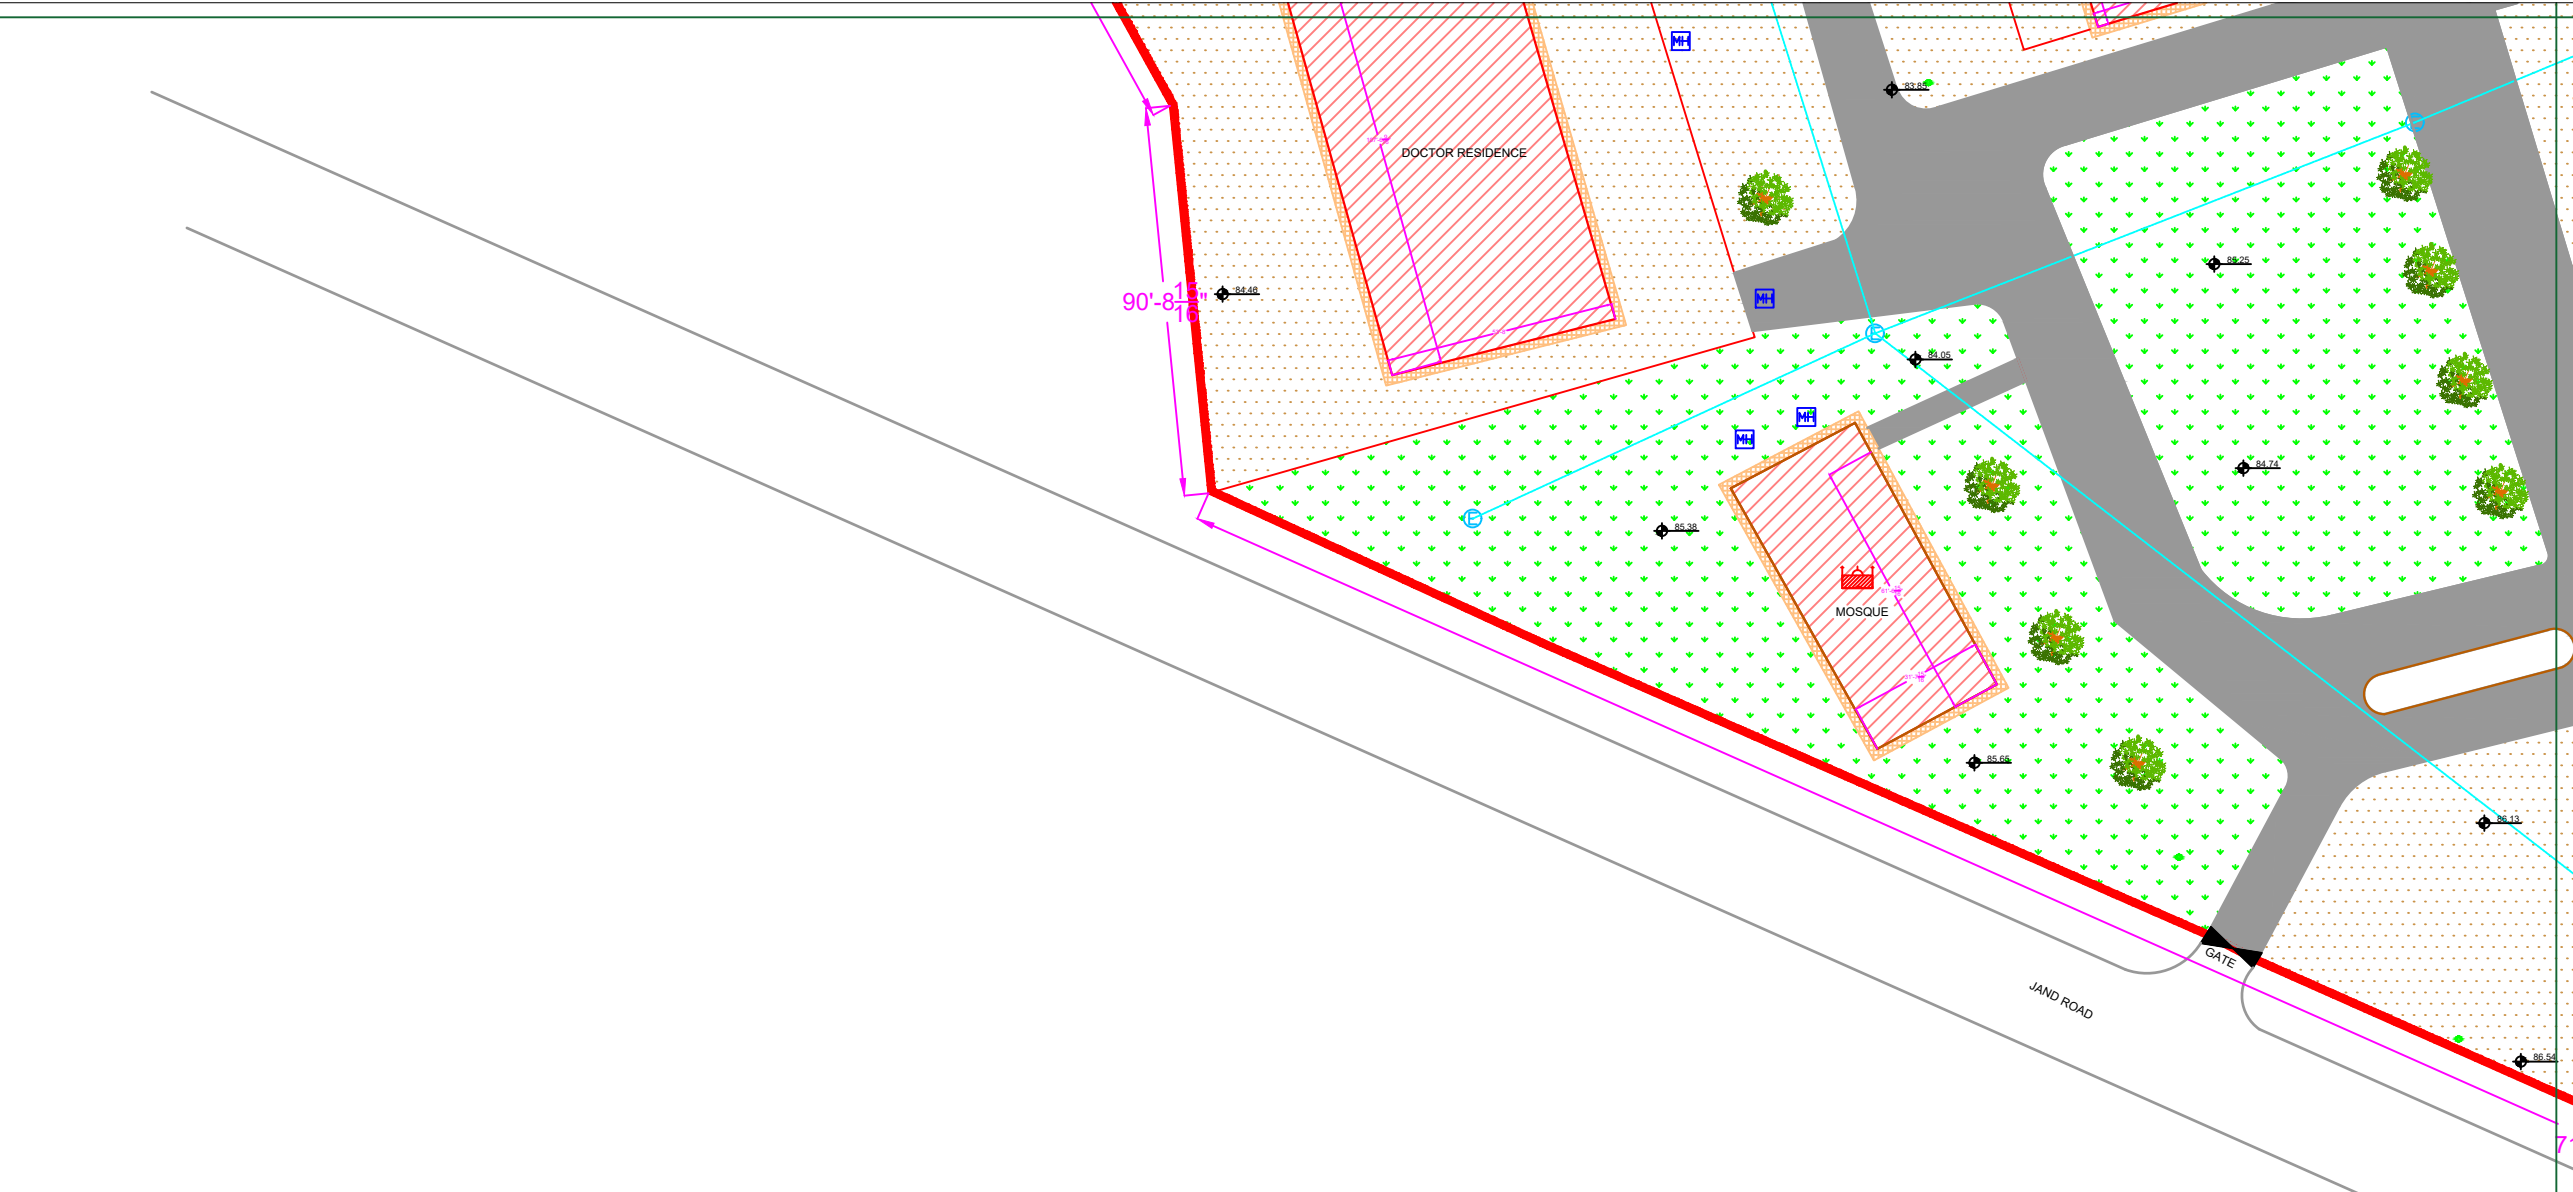

Legends:	
Residential Area	
Road	
Wall	
Power Line	
OHT	
Tree	
Man Hole	
Tube Well	
Light Pole	
Lawns	
Earthen Areas	
Asphalts Roads	
Tough Pavers	
P.C.C / Plinth Protection	
Boundary Wall	
Brick Pavers / Soling	
Drain	
Tap	
Hand Pump	
Air Conditioner	
Tube Light	
Fan	
Roof Light	
Bulb	

AREA	
AREA WITHIN BOUNDARY WALL	350102.606 Sft
AREA OF CLINICAL BLOCK	24511.362 Sft
PLINTH AREA OF BLOCK	24511.362 Sft

OPENING SCHEDULE OF DOORS AND WINDOWS					
DOORS	WIDTH	HEIGHT	WINDOWS	WIDTH	HEIGHT
D1	5'-6"	7'-0"	W1	3'-0"	3'-0"
D2	5'-0"	7'-0"	W2	3'-6"	3'-6"
D3	4'-0"	7'-0"	W3	6'-0"	6'-0"
D4	3'-6"	7'-0"	W4	4'-6"	4'-6"
D5	3'-0"	7'-0"	W5	8'-6"	8'-6"
D6	2'-6"	7'-0"	W6	2'-6"	2'-6"
D7	6'-0"	7'-0"	W7	4'-0"	4'-0"
V1	1'-6"	1'-6"	W8	5'-0"	5'-0"
V2	2'-0"	2'-0"	W9	2'-0"	2'-0"

Project:
**CAD MAPPING OF TEHSIL
HEAD QUARTER HOSPITALS,
PUNJAB**


Client: GOVERNMENT OF THE PUNJAB PRIMARY & SECONDARY HEALTHCARE DEPARTMENT	Consultant: SKAFS CONSULTANT (Pvt.) Limited ENGINEERING AND ENVIRONMENT CONSULTANT
---	--

Drawing Title: **THQ JAND
HOSPITAL MASTER PLAN PART 3**

Drawing No. **SKAFS/JAND /06**

MASTER PLAN OF THQ HOSPITAL JAND

PART 4

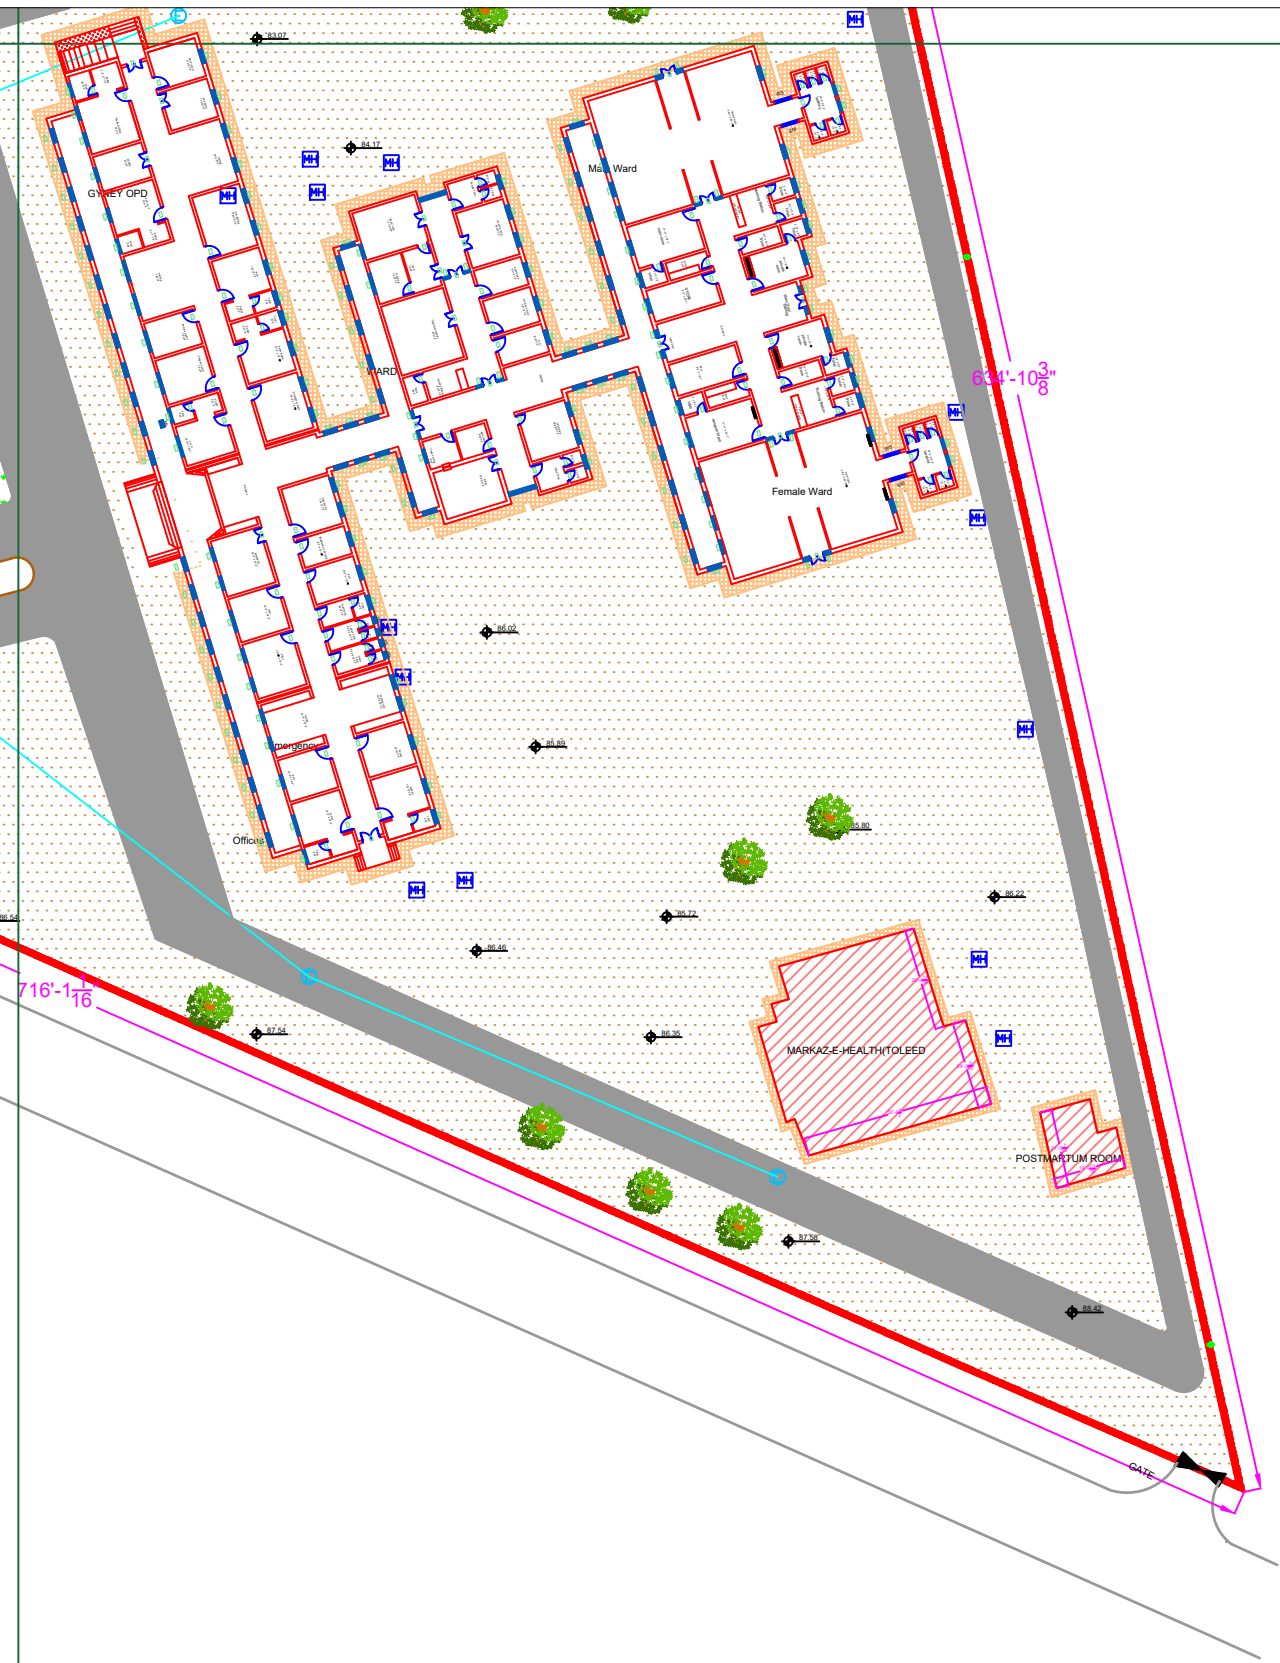

Legends:

Residential Area	
Road	
Wall	
Power Line	
OHT	
Tree	
Man Hole	
Tube Well	
Light Pole	
Lawns	
Earthen Areas	
Asphalts Roads	
Tough Pavers	
P.C.C / Plinth Protection	
Boundary Wall	
Brick Pavers / Soling	
Drain	
Tap	
Hand Pump	
Air Conditioner	
Tube Light	
Fan	
Roof Light	
Bulb	

AREA	
AREA WITHIN BOUNDARY WALL	350102.606 Sft
AREA OF CLINICAL BLOCK	24511.362 Sft
PLINTH AREA OF BLOCK	24511.362 Sft


OPENING SCHEDULE OF DOORS AND WINDOWS					
DOORS	WIDTH	HEIGHT	WINDOWS	WIDTH	HEIGHT
D1	5'-6"	7'-0"	W1	3'-0"	3'-0"
D2	5'-0"	7'-0"	W2	3'-6"	3'-6"
D3	4'-0"	7'-0"	W3	6'-0"	6'-0"
D4	3'-6"	7'-0"	W4	4'-6"	4'-6"
D5	3'-0"	7'-0"	W5	8'-6"	8'-6"
D6	2'-6"	7'-0"	W6	2'-6"	2'-6"
D7	6'-0"	7'-0"	W7	4'-0"	4'-0"
V1	1'-6"	1'-6"	W8	5'-0"	5'-0"
V2	2'-0"	2'-0"	W9	2'-0"	2'-0"

Project:
**CAD MAPPING OF TEHSIL
HEAD QUARTER HOSPITALS,
PUNJAB**

Client: GOVERNMENT OF THE PUNJAB PRIMARY & SECONDARY HEALTHCARE DEPARTMENT	Consultant: SKAFS CONSULTANT (Pvt.) Limited ENGINEERING AND ENVIRONMENT CONSULTANT
---	--


Drawing Title:
**THQ JAND
HOSPITAL MASTER PLAN PART 4**

Drawing No.
SKAFS/JAND /07

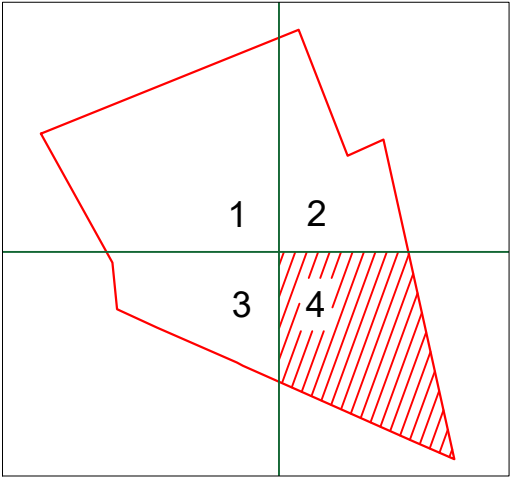

CLINICAL BLOCK OF THQ HOSPITAL JAND

GROUND FLOOR

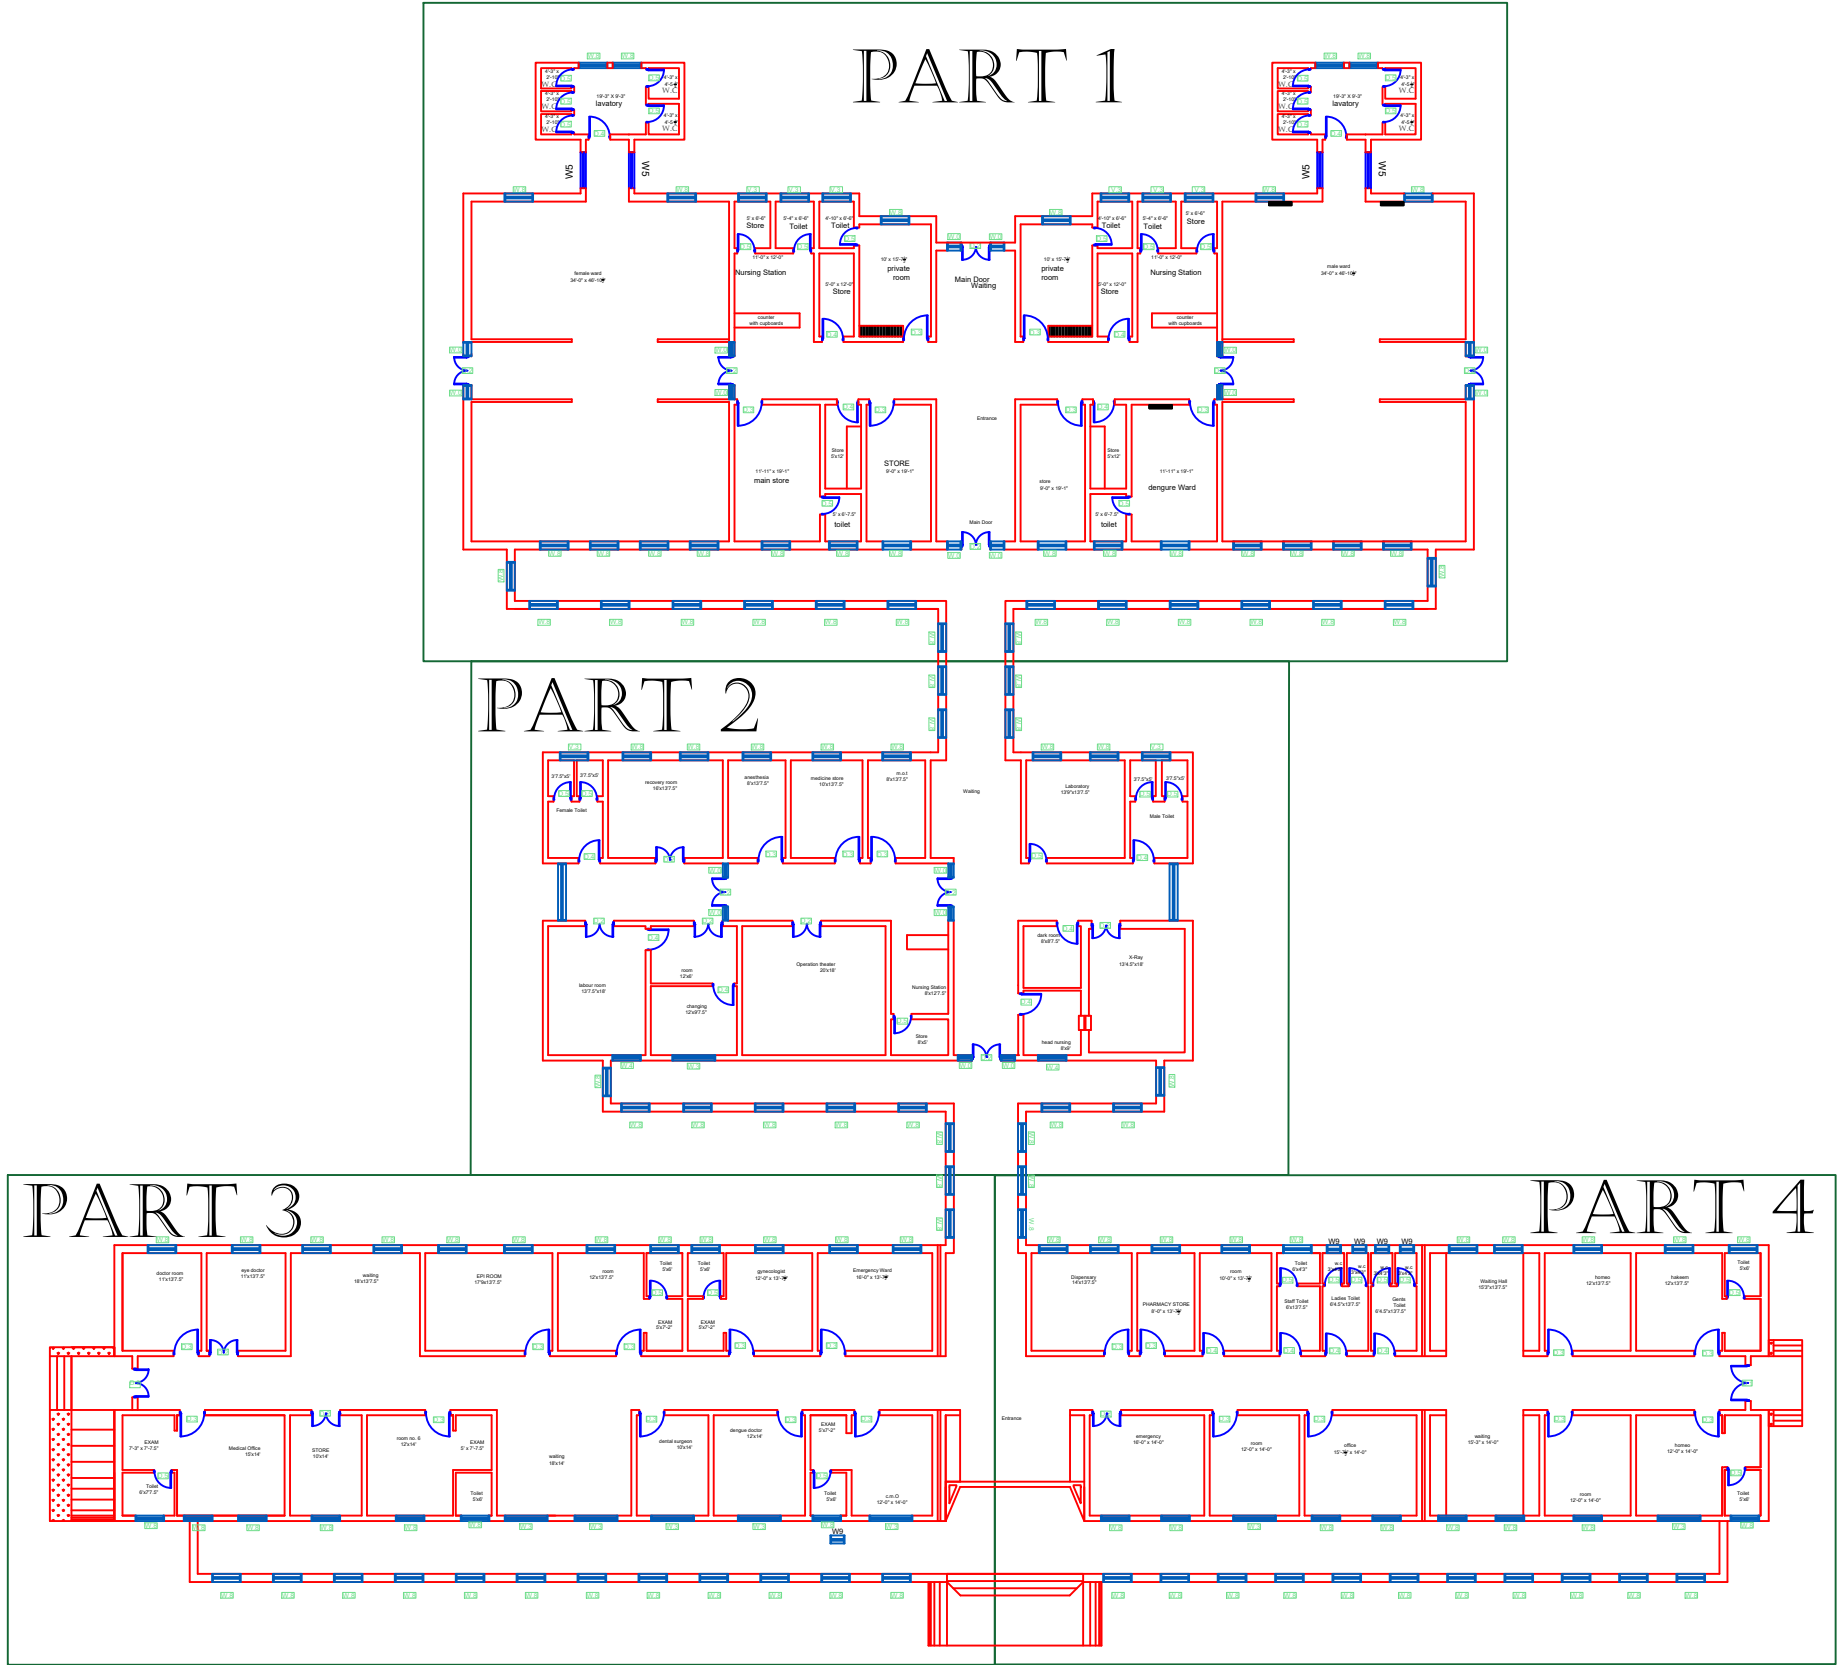

Legends:

Residential Area	
Road	
Wall	
Power Line	
OHT	
Tree	
Man Hole	
Tube Well	
Light Pole	
Lawns	
Earthen Areas	
Asphalts Roads	
Tough Pavers	
P.C.C / Plinth Protection	
Boundary Wall	
Brick Pavers / Soling	
Drain	
Tap	
Hand Pump	
Air Conditioner	
Tube Light	
Fan	
Roof Light	
Bulb	

AREA					
AREA WITHIN BOUNDARY WALL		350102.606 Sft			
AREA OF CLINICAL BLOCK		24511.362 Sft			
PLINTH AREA OF BLOCK		24511.362 Sft			

OPENING SCHEDULE OF DOORS AND WINDOWS					
DOORS	WIDTH	HEIGHT	WINDOWS	WIDTH	HEIGHT
D1	5'-6"	7'-0"	W1	3'-0"	3'-0"
D2	5'-0"	7'-0"	W2	3'-6"	3'-6"
D3	4'-0"	7'-0"	W3	6'-0"	6'-0"
D4	3'-6"	7'-0"	W4	4'-6"	4'-6"
D5	3'-0"	7'-0"	W5	8'-6"	8'-6"
D6	2'-6"	7'-0"	W6	2'-6"	2'-6"
D7	6'-0"	7'-0"	W7	4'-0"	4'-0"
V1	1'-6"	1'-6"	W8	5'-0"	5'-0"
V2	2'-0"	2'-0"	W9	2'-0"	2'-0"

Project:

CAD MAPPING OF TEHSIL HEAD QUARTER HOSPITALS, PUNJAB

Client:	Consultant:
 GOVERNMENT OF THE PUNJAB PRIMARY & SECONDARY HEALTHCARE DEPARTMENT	 SKAFS CONSULTANT (Pvt.) Limited ENGINEERING AND ENVIRONMENT CONSULTANT

Drawing Title:


THQ JAND HOSPITAL CLINICAL BLOCK PLAN

Drawing No.

SKAFS/JAND /08

CLINICAL BLOCK OF THQ HOSPITAL JAND

GROUND FLOOR PART 1

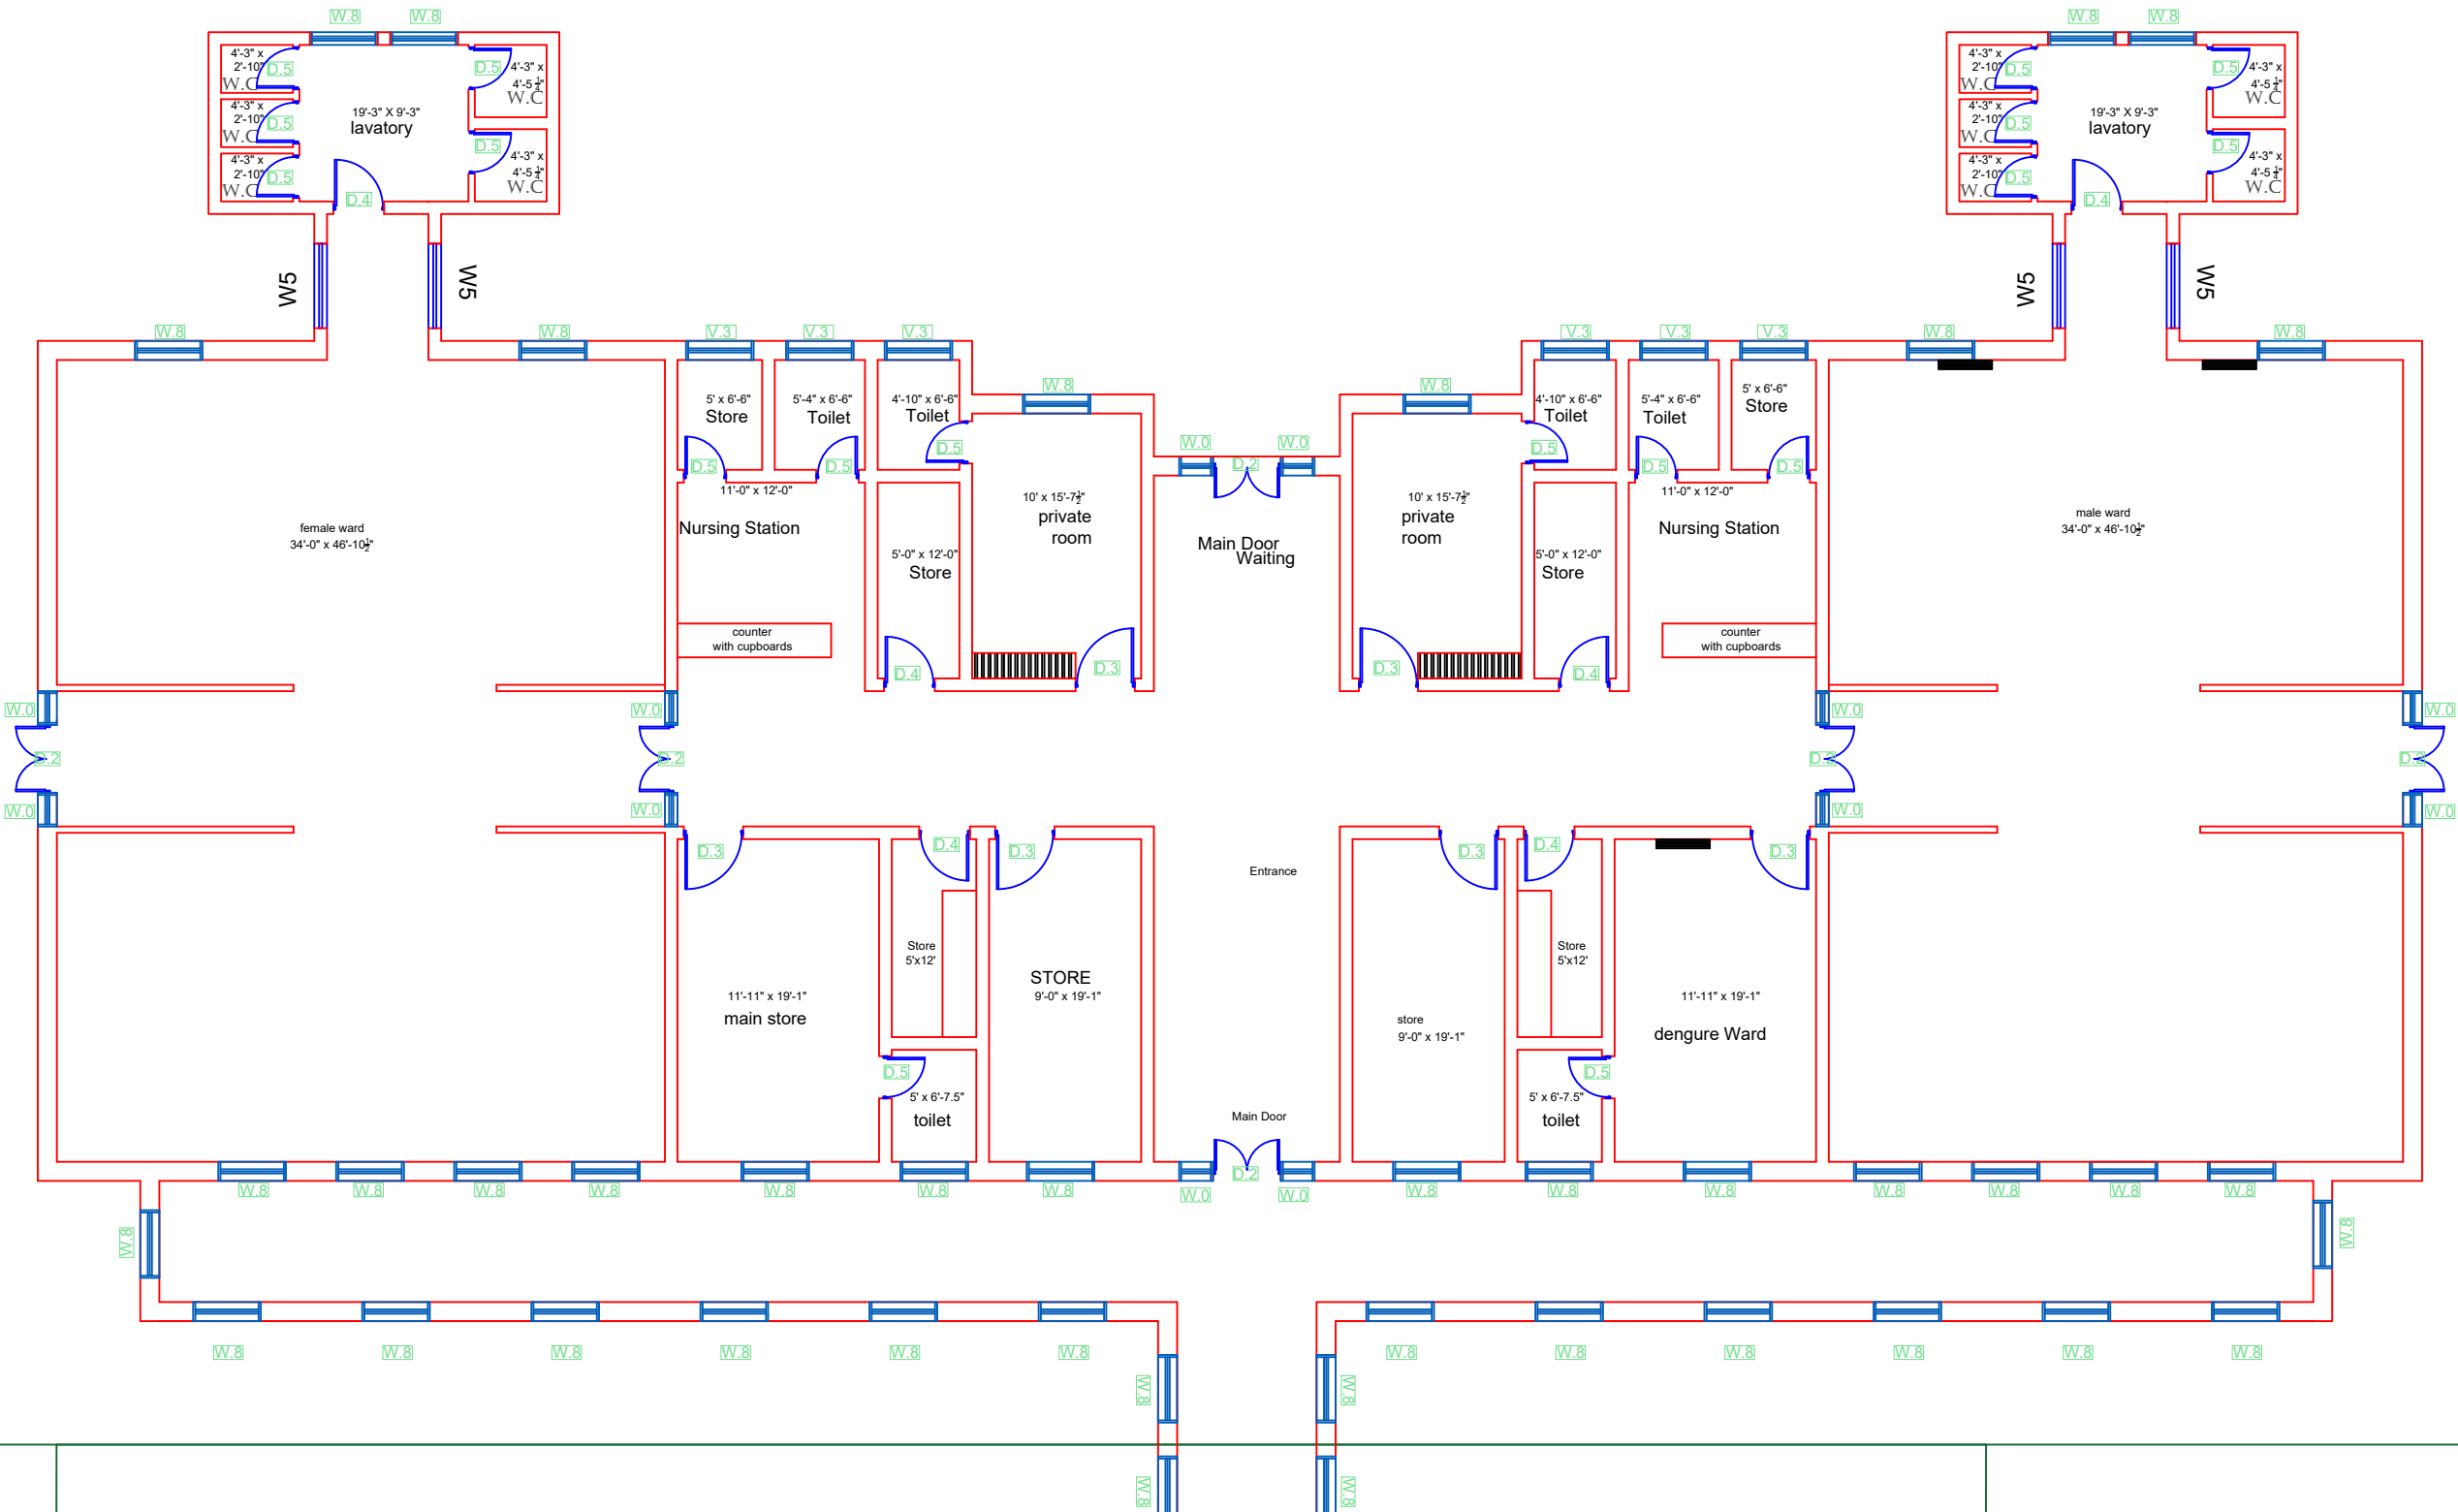

Legends:

Residential Area	
Road	
Wall	
Power Line	
OHT	
Tree	
Man Hole	
Tube Well	
Light Pole	
Lawns	
Earthen Areas	
Asphalts Roads	
Tough Pavers	
P.C.C / Plinth Protection	
Boundary Wall	
Brick Pavers / Soling	
Drain	
Tap	
Hand Pump	
Air Conditioner	
Tube Light	
Fan	
Roof Light	
Bulb	

AREA					
AREA WITHIN BOUNDARY WALL		350102.606 Sft			
AREA OF CLINICAL BLOCK		24511.362 Sft			
PLINTH AREA OF BLOCK		24511.362 Sft			

OPENING SCHEDULE OF DOORS AND WINDOWS					
DOORS	WIDTH	HEIGHT	WINDOWS	WIDTH	HEIGHT
D1	5'-6"	7'-0"	W1	3'-0"	3'-0"
D2	5'-0"	7'-0"	W2	3'-6"	3'-6"
D3	4'-0"	7'-0"	W3	6'-0"	6'-0"
D4	3'-6"	7'-0"	W4	4'-6"	4'-6"
D5	3'-0"	7'-0"	W5	8'-6"	8'-6"
D6	2'-6"	7'-0"	W6	2'-6"	2'-6"
D7	6'-0"	7'-0"	W7	4'-0"	4'-0"
V1	1'-6"	1'-6"	W8	5'-0"	5'-0"
V2	2'-0"	2'-0"	W9	2'-0"	2'-0"

Project:
CAD MAPPING OF TEHSIL HEAD QUARTER HOSPITALS, PUNJAB

Client: GOVERNMENT OF THE PUNJAB PRIMARY & SECONDARY HEALTHCARE DEPARTMENT	Consultant: SKAFS CONSULTANT (Pvt.) Limited ENGINEERING AND ENVIRONMENT CONSULTANT
---	---

Drawing Title:
THQ JAND CLINICAL BLOCK PLAN (PART 1)

Drawing No.
SKAFS/JAND /09

CLINICAL BLOCK OF THQ HOSPITAL JAND

GROUND FLOOR PART 2

Legends:

Residential Area	
Road	
Wall	
Power Line	
OHT	
Tree	
Man Hole	
Tube Well	
Light Pole	
Lawns	
Earthen Areas	
Asphalts Roads	
Tough Pavers	
P.C.C / Plinth Protection	
Boundary Wall	
Brick Pavers / Soling	
Drain	
Tap	
Hand Pump	
Air Conditioner	
Tube Light	
Fan	
Roof Light	
Bulb	

AREA	
AREA WITHIN BOUNDARY WALL	350102.606 Sft
AREA OF CLINICAL BLOCK	24511.362 Sft
PLINTH AREA OF BLOCK	24511.362 Sft

OPENING SCHEDULE OF DOORS AND WINDOWS					
DOORS	WIDTH	HEIGHT	WINDOWS	WIDTH	HEIGHT
D1	5'-6"	7'-0"	W1	3'-0"	3'-0"
D2	5'-0"	7'-0"	W2	3'-6"	3'-6"
D3	4'-0"	7'-0"	W3	6'-0"	6'-0"
D4	3'-6"	7'-0"	W4	4'-6"	4'-6"
D5	3'-0"	7'-0"	W5	8'-6"	8'-6"
D6	2'-6"	7'-0"	W6	2'-6"	2'-6"
D7	6'-0"	7'-0"	W7	4'-0"	4'-0"
V1	1'-6"	1'-6"	W8	5'-0"	5'-0"
V2	2'-0"	2'-0"	W9	2'-0"	2'-0"

Project:
**CAD MAPPING OF TEHSIL
HEAD QUARTER HOSPITALS,
PUNJAB**


Client: GOVERNMENT OF THE PUNJAB PRIMARY & SECONDARY HEALTHCARE DEPARTMENT	Consultant: SKAFS CONSULTANT (Pvt.) Limited ENGINEERING AND ENVIRONMENT CONSULTANT
---	--

Drawing Title:
**THQ JAND
CLINICAL BLOCK PLAN (PART 2)**

Drawing No.
SKAFS/JAND /10

CLINICAL BLOCK OF THQ HOSPITAL JAND

GROUND FLOOR PART 3

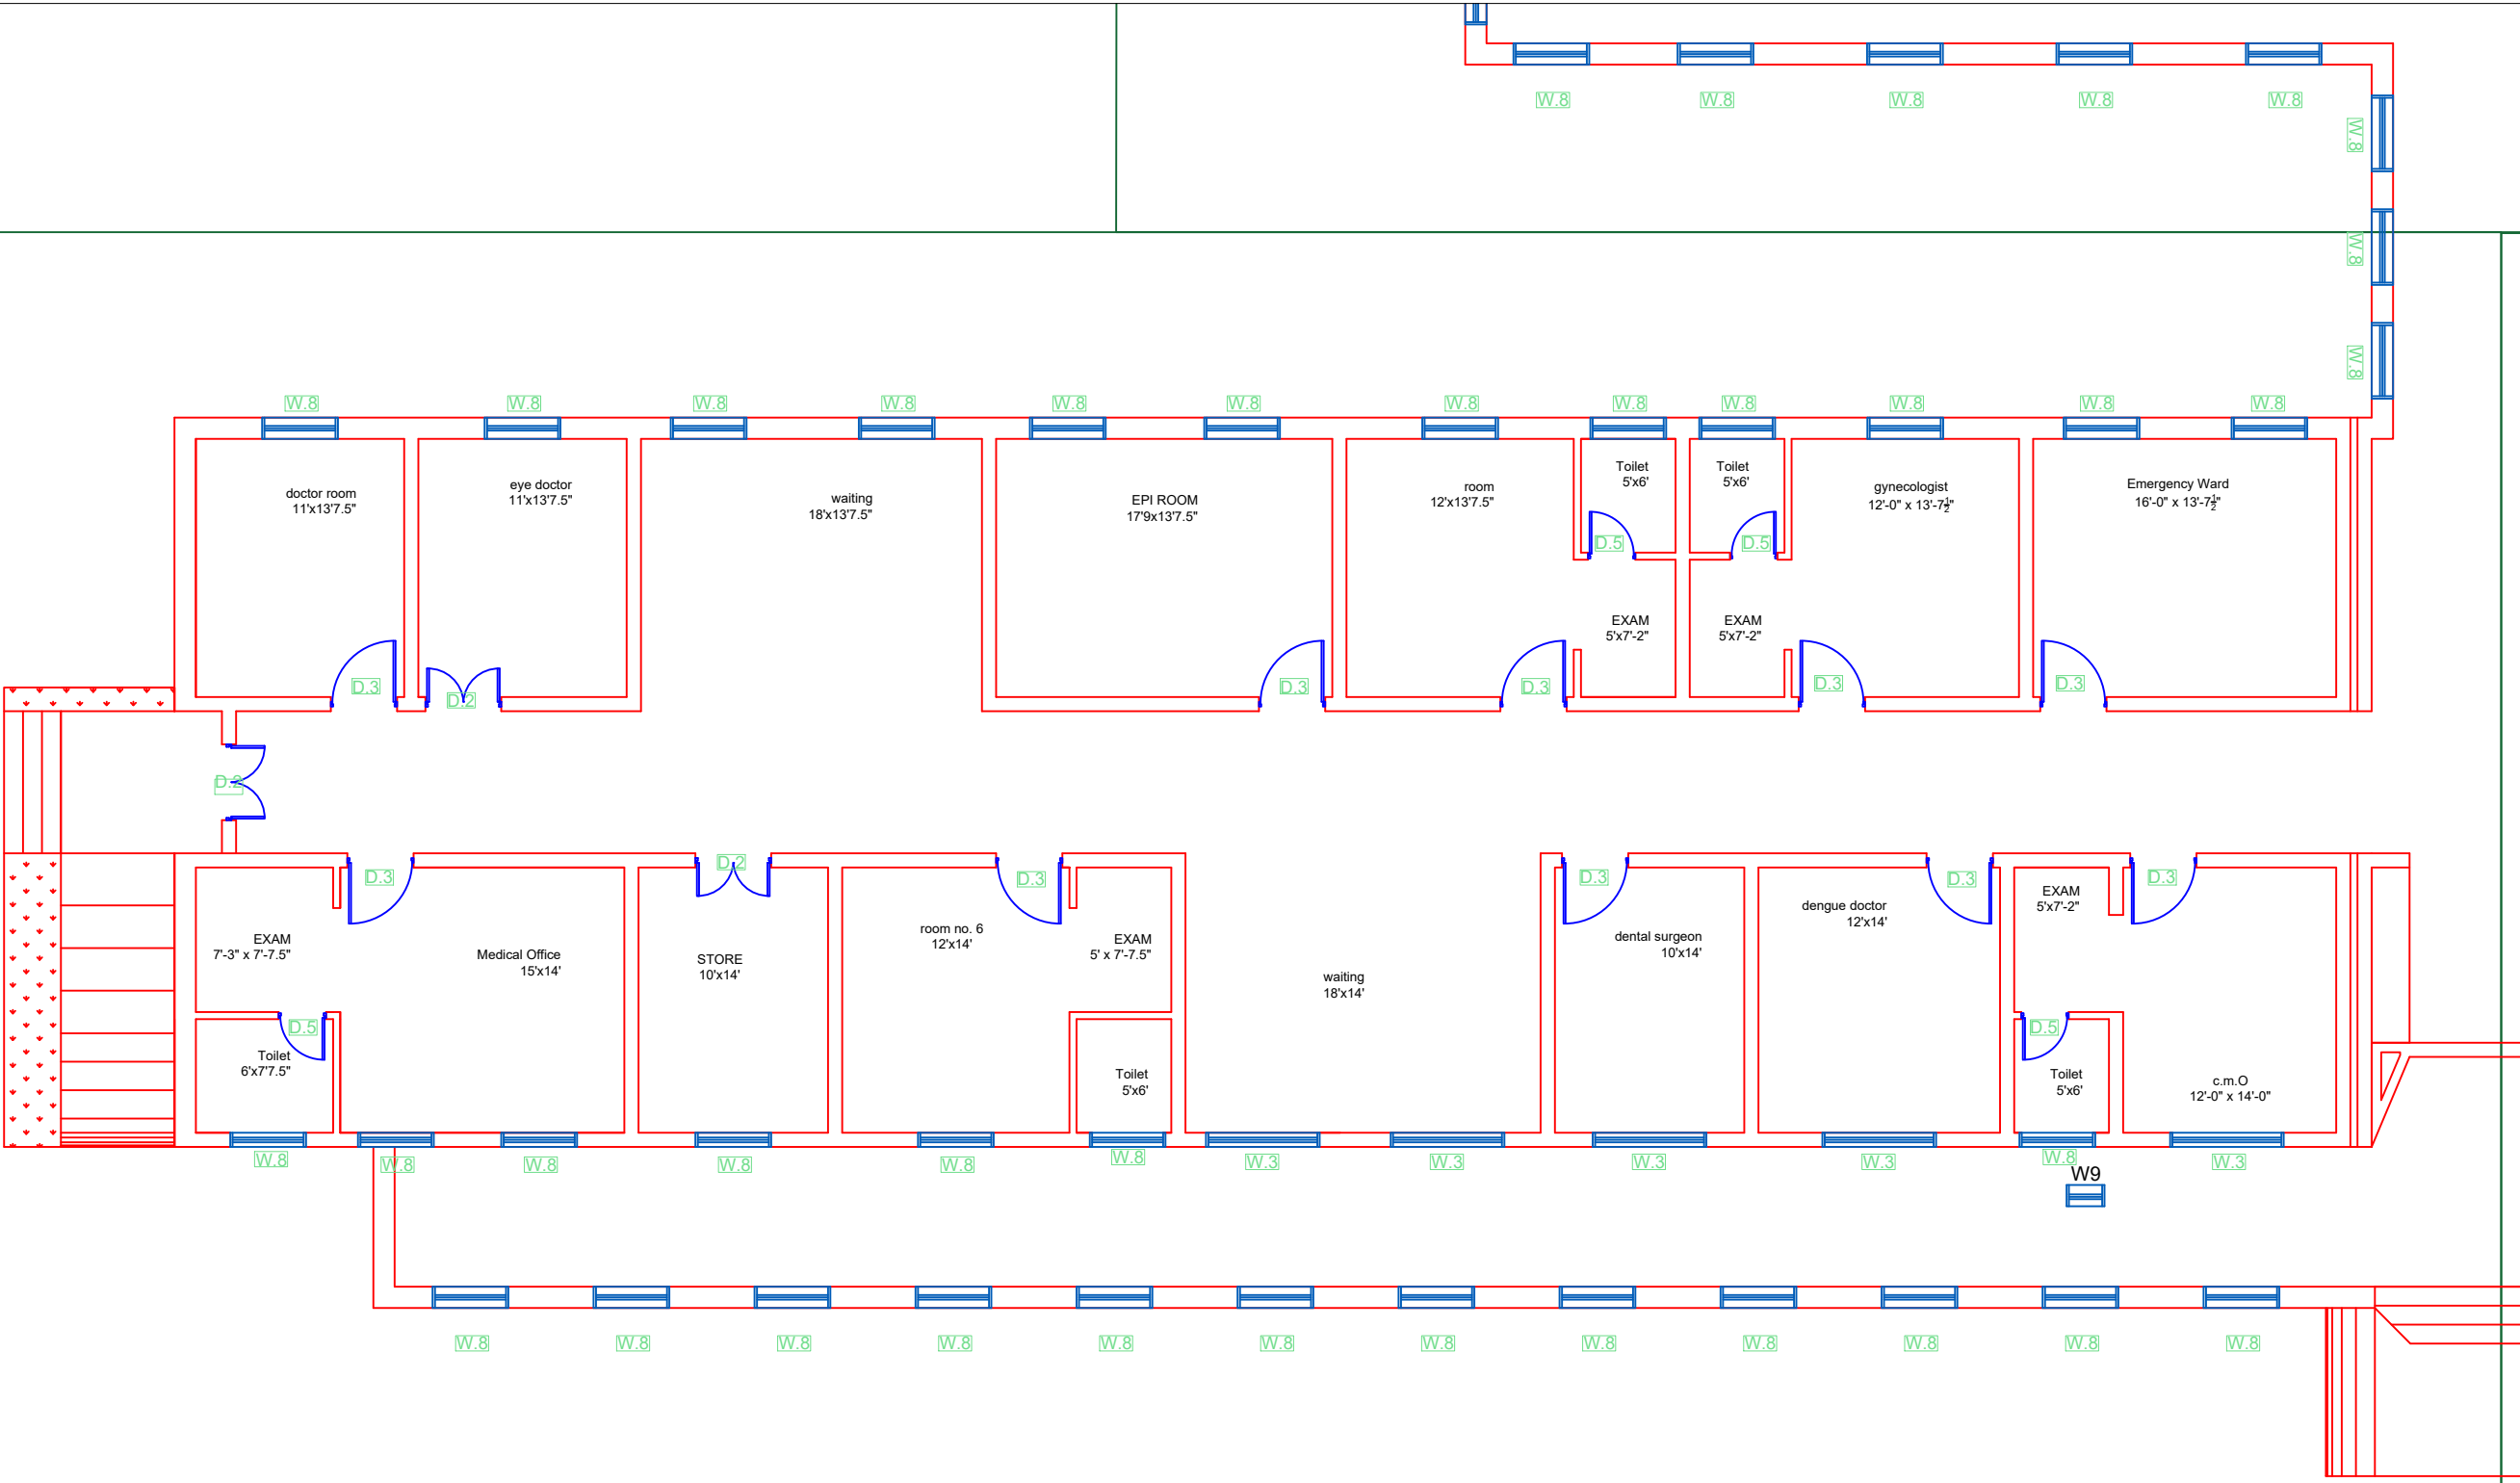

Legends:

Residential Area	
Road	
Wall	
Power Line	
OHT	
Tree	
Man Hole	
Tube Well	
Light Pole	
Lawns	
Earthen Areas	
Asphalts Roads	
Tough Pavers	
P.C.C / Plinth Protection	
Boundary Wall	
Brick Pavers / Soling	
Drain	
Tap	
Hand Pump	
Air Conditioner	
Tube Light	
Fan	
Roof Light	
Bulb	

AREA	
AREA WITHIN BOUNDARY WALL	350102.606 Sft
AREA OF CLINICAL BLOCK	24511.362 Sft
PLINTH AREA OF BLOCK	24511.362 Sft

OPENING SCHEDULE OF DOORS AND WINDOWS					
DOORS	WIDTH	HEIGHT	WINDOWS	WIDTH	HEIGHT
D1	5'-6"	7'-0"	W1	3'-0"	3'-0"
D2	5'-0"	7'-0"	W2	3'-6"	3'-6"
D3	4'-0"	7'-0"	W3	6'-0"	6'-0"
D4	3'-6"	7'-0"	W4	4'-6"	4'-6"
D5	3'-0"	7'-0"	W5	8'-6"	8'-6"
D6	2'-6"	7'-0"	W6	2'-6"	2'-6"
D7	6'-0"	7'-0"	W7	4'-0"	4'-0"
V1	1'-6"	1'-6"	W8	5'-0"	5'-0"
V2	2'-0"	2'-0"	W9	2'-0"	2'-0"

Project:

**CAD MAPPING OF TEHSIL
HEAD QUARTER HOSPITALS,
PUNJAB**

Client:

GOVERNMENT OF THE PUNJAB
PRIMARY & SECONDARY
HEALTHCARE DEPARTMENT

Consultant:

SKAFS CONSULTANT (Pvt.)
Limited
ENGINEERING AND ENVIRONMENT
CONSULTANT

Drawing Title:


**THQ JAND
CLINICAL BLOCK PLAN (PART 3)**

Drawing No.

SKAFS/JAND /11

CLINICAL BLOCK OF THQ HOSPITAL JAND

GROUND FLOOR PART 4

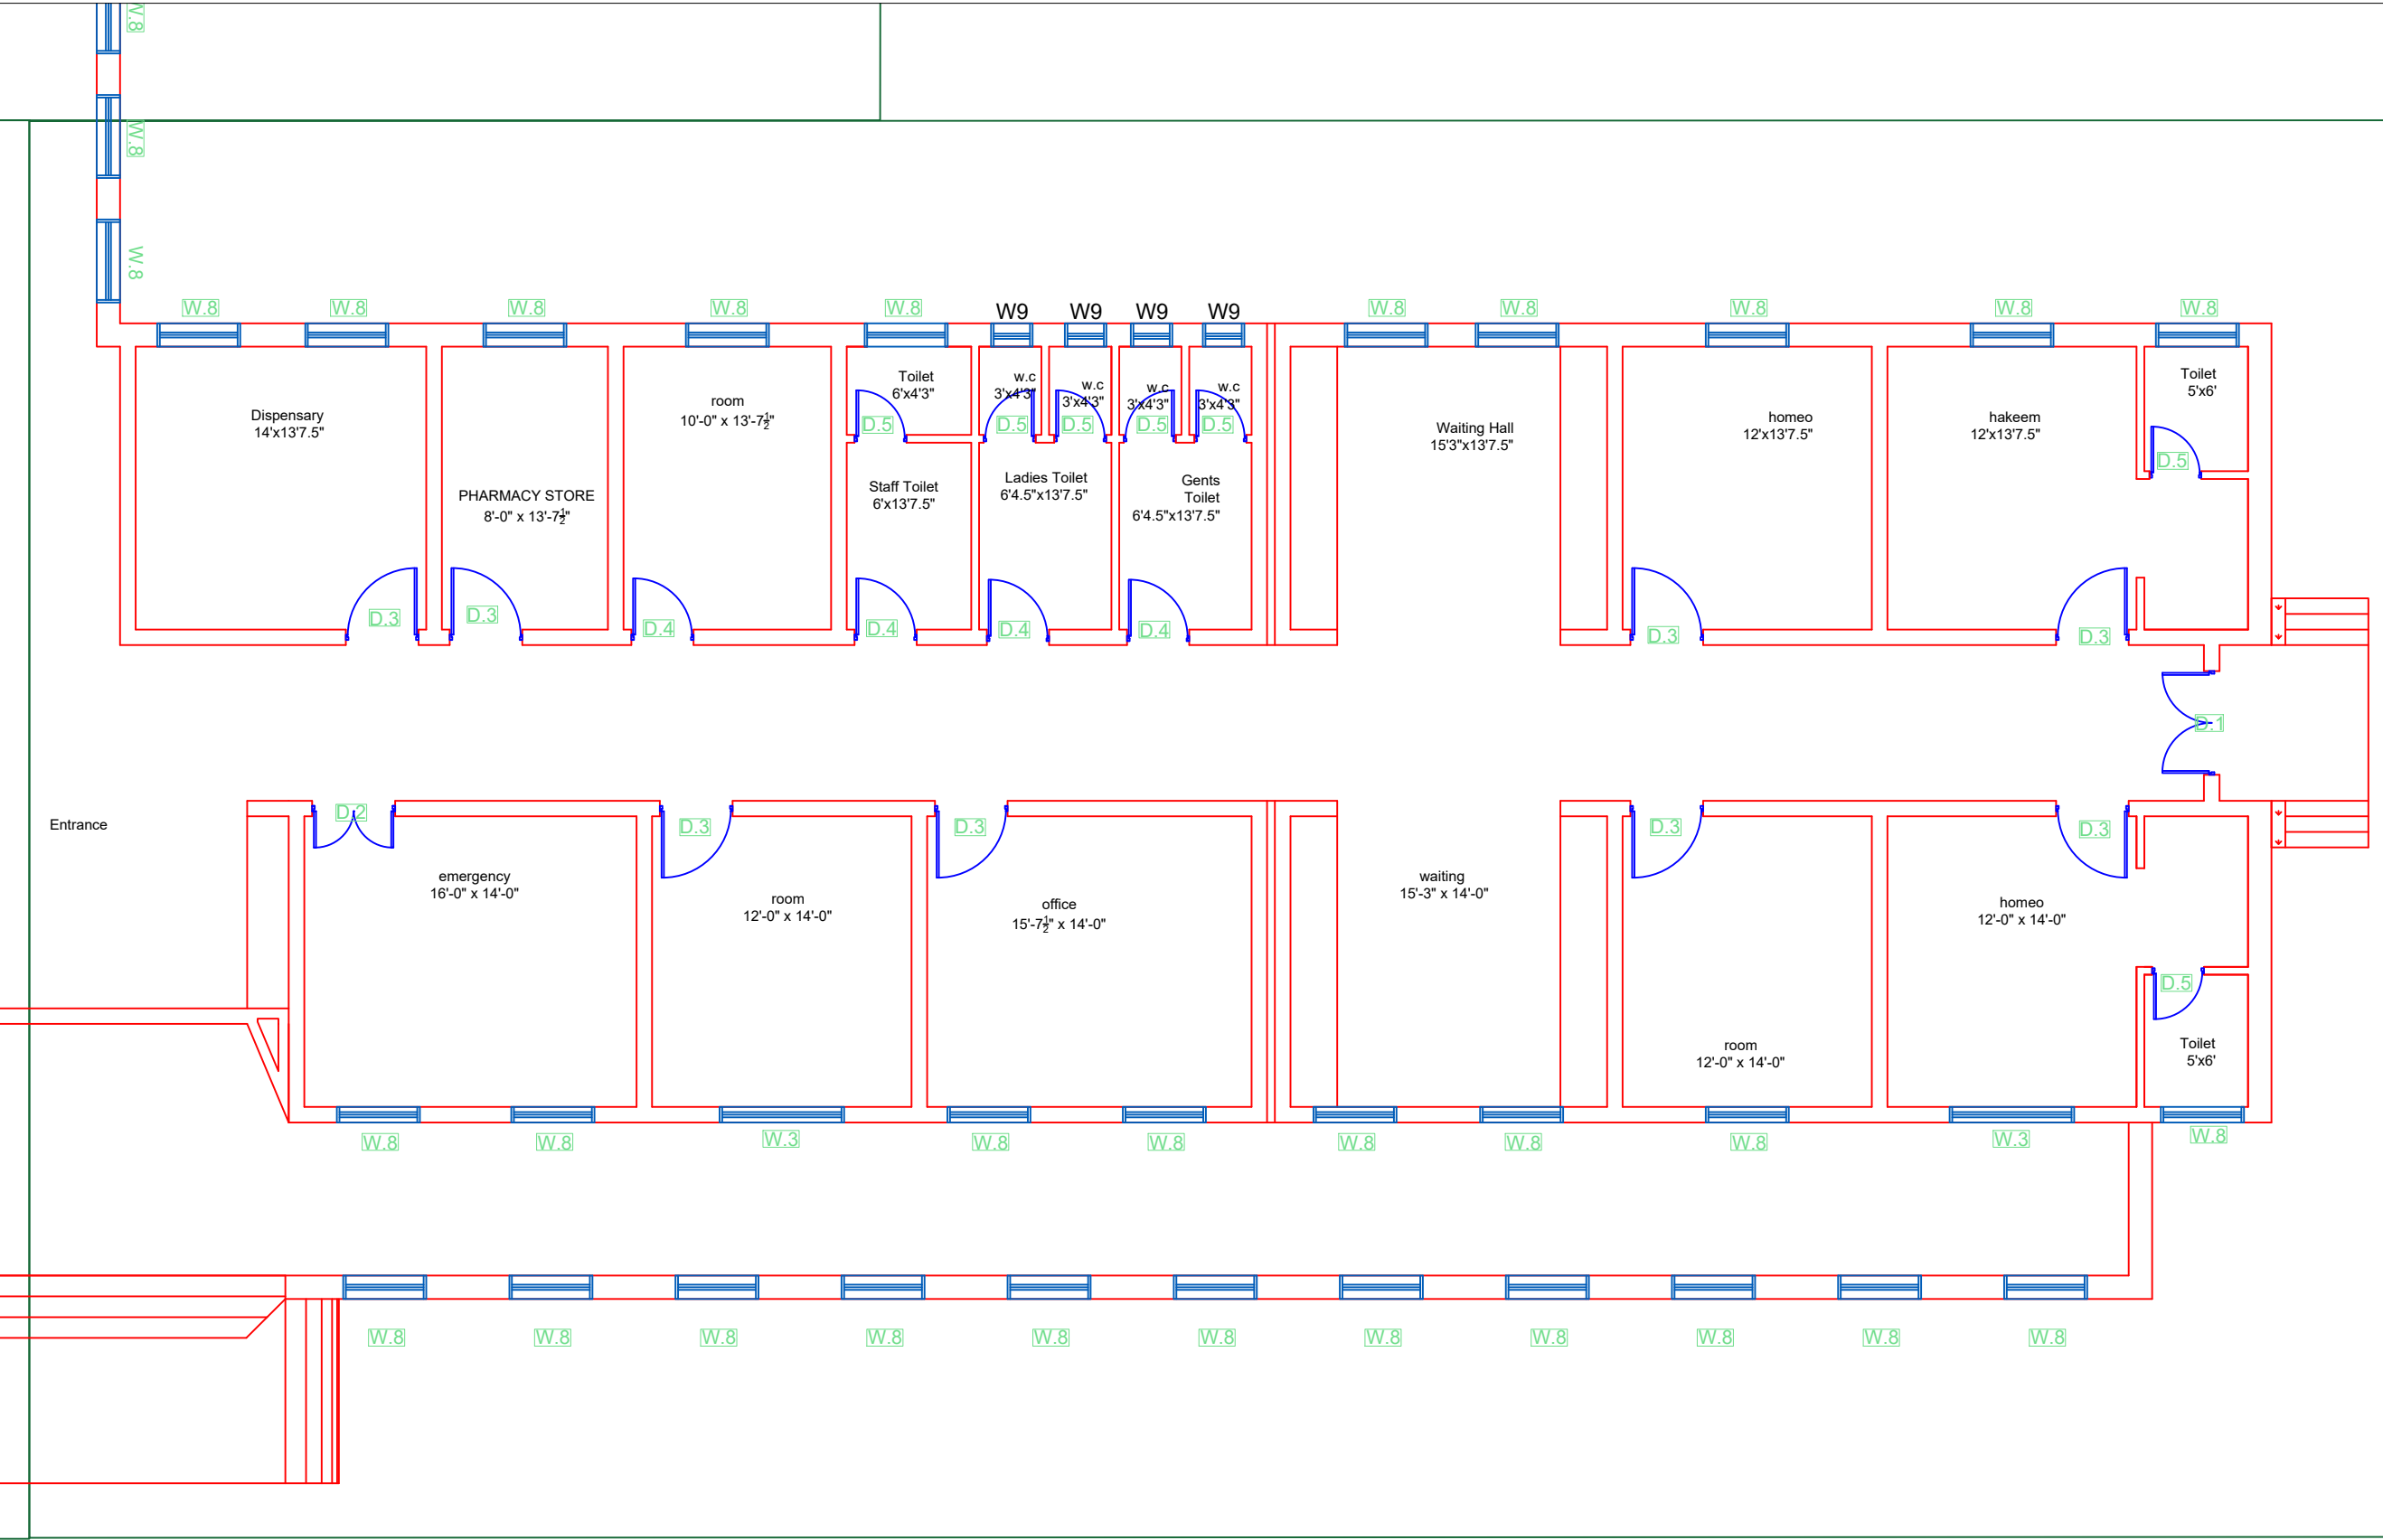

Legends:

Residential Area	
Road	
Wall	
Power Line	
OHT	
Tree	
Man Hole	
Tube Well	
Light Pole	
Lawns	
Earthen Areas	
Asphalts Roads	
Tough Pavers	
P.C.C / Plinth Protection	
Boundary Wall	
Brick Pavers / Soling	
Drain	
Tap	
Hand Pump	
Air Conditioner	
Tube Light	
Fan	
Roof Light	
Bulb	

AREA					
AREA WITHIN BOUNDARY WALL		350102.606 Sft			
AREA OF CLINICAL BLOCK		24511.362 Sft			
PLINTH AREA OF BLOCK		24511.362 Sft			

OPENING SCHEDULE OF DOORS AND WINDOWS					
DOORS	WIDTH	HEIGHT	WINDOWS	WIDTH	HEIGHT
D1	5'-6"	7'-0"	W1	3'-0"	3'-0"
D2	5'-0"	7'-0"	W2	3'-6"	3'-6"
D3	4'-0"	7'-0"	W3	6'-0"	6'-0"
D4	3'-6"	7'-0"	W4	4'-6"	4'-6"
D5	3'-0"	7'-0"	W5	8'-6"	8'-6"
D6	2'-6"	7'-0"	W6	2'-6"	2'-6"
D7	6'-0"	7'-0"	W7	4'-0"	4'-0"
V1	1'-6"	1'-6"	W8	5'-0"	5'-0"
V2	2'-0"	2'-0"	W9	2'-0"	2'-0"

Project:
**CAD MAPPING OF TEHSIL
HEAD QUARTER HOSPITALS,
PUNJAB**


Client: GOVERNMENT OF THE PUNJAB PRIMARY & SECONDARY HEALTHCARE DEPARTMENT	Consultant: SKAFS CONSULTANT (Pvt.) Limited ENGINEERING AND ENVIRONMENT CONSULTANT
---	--

Drawing Title: **THQ JAND
CLINICAL BLOCK PLAN (PART 4)**

Drawing No. **SKAFS/JAND /12**

ELECTRICAL LAYOUT PLAN OF THQ HOSPITAL JAND

GROUND FLOOR

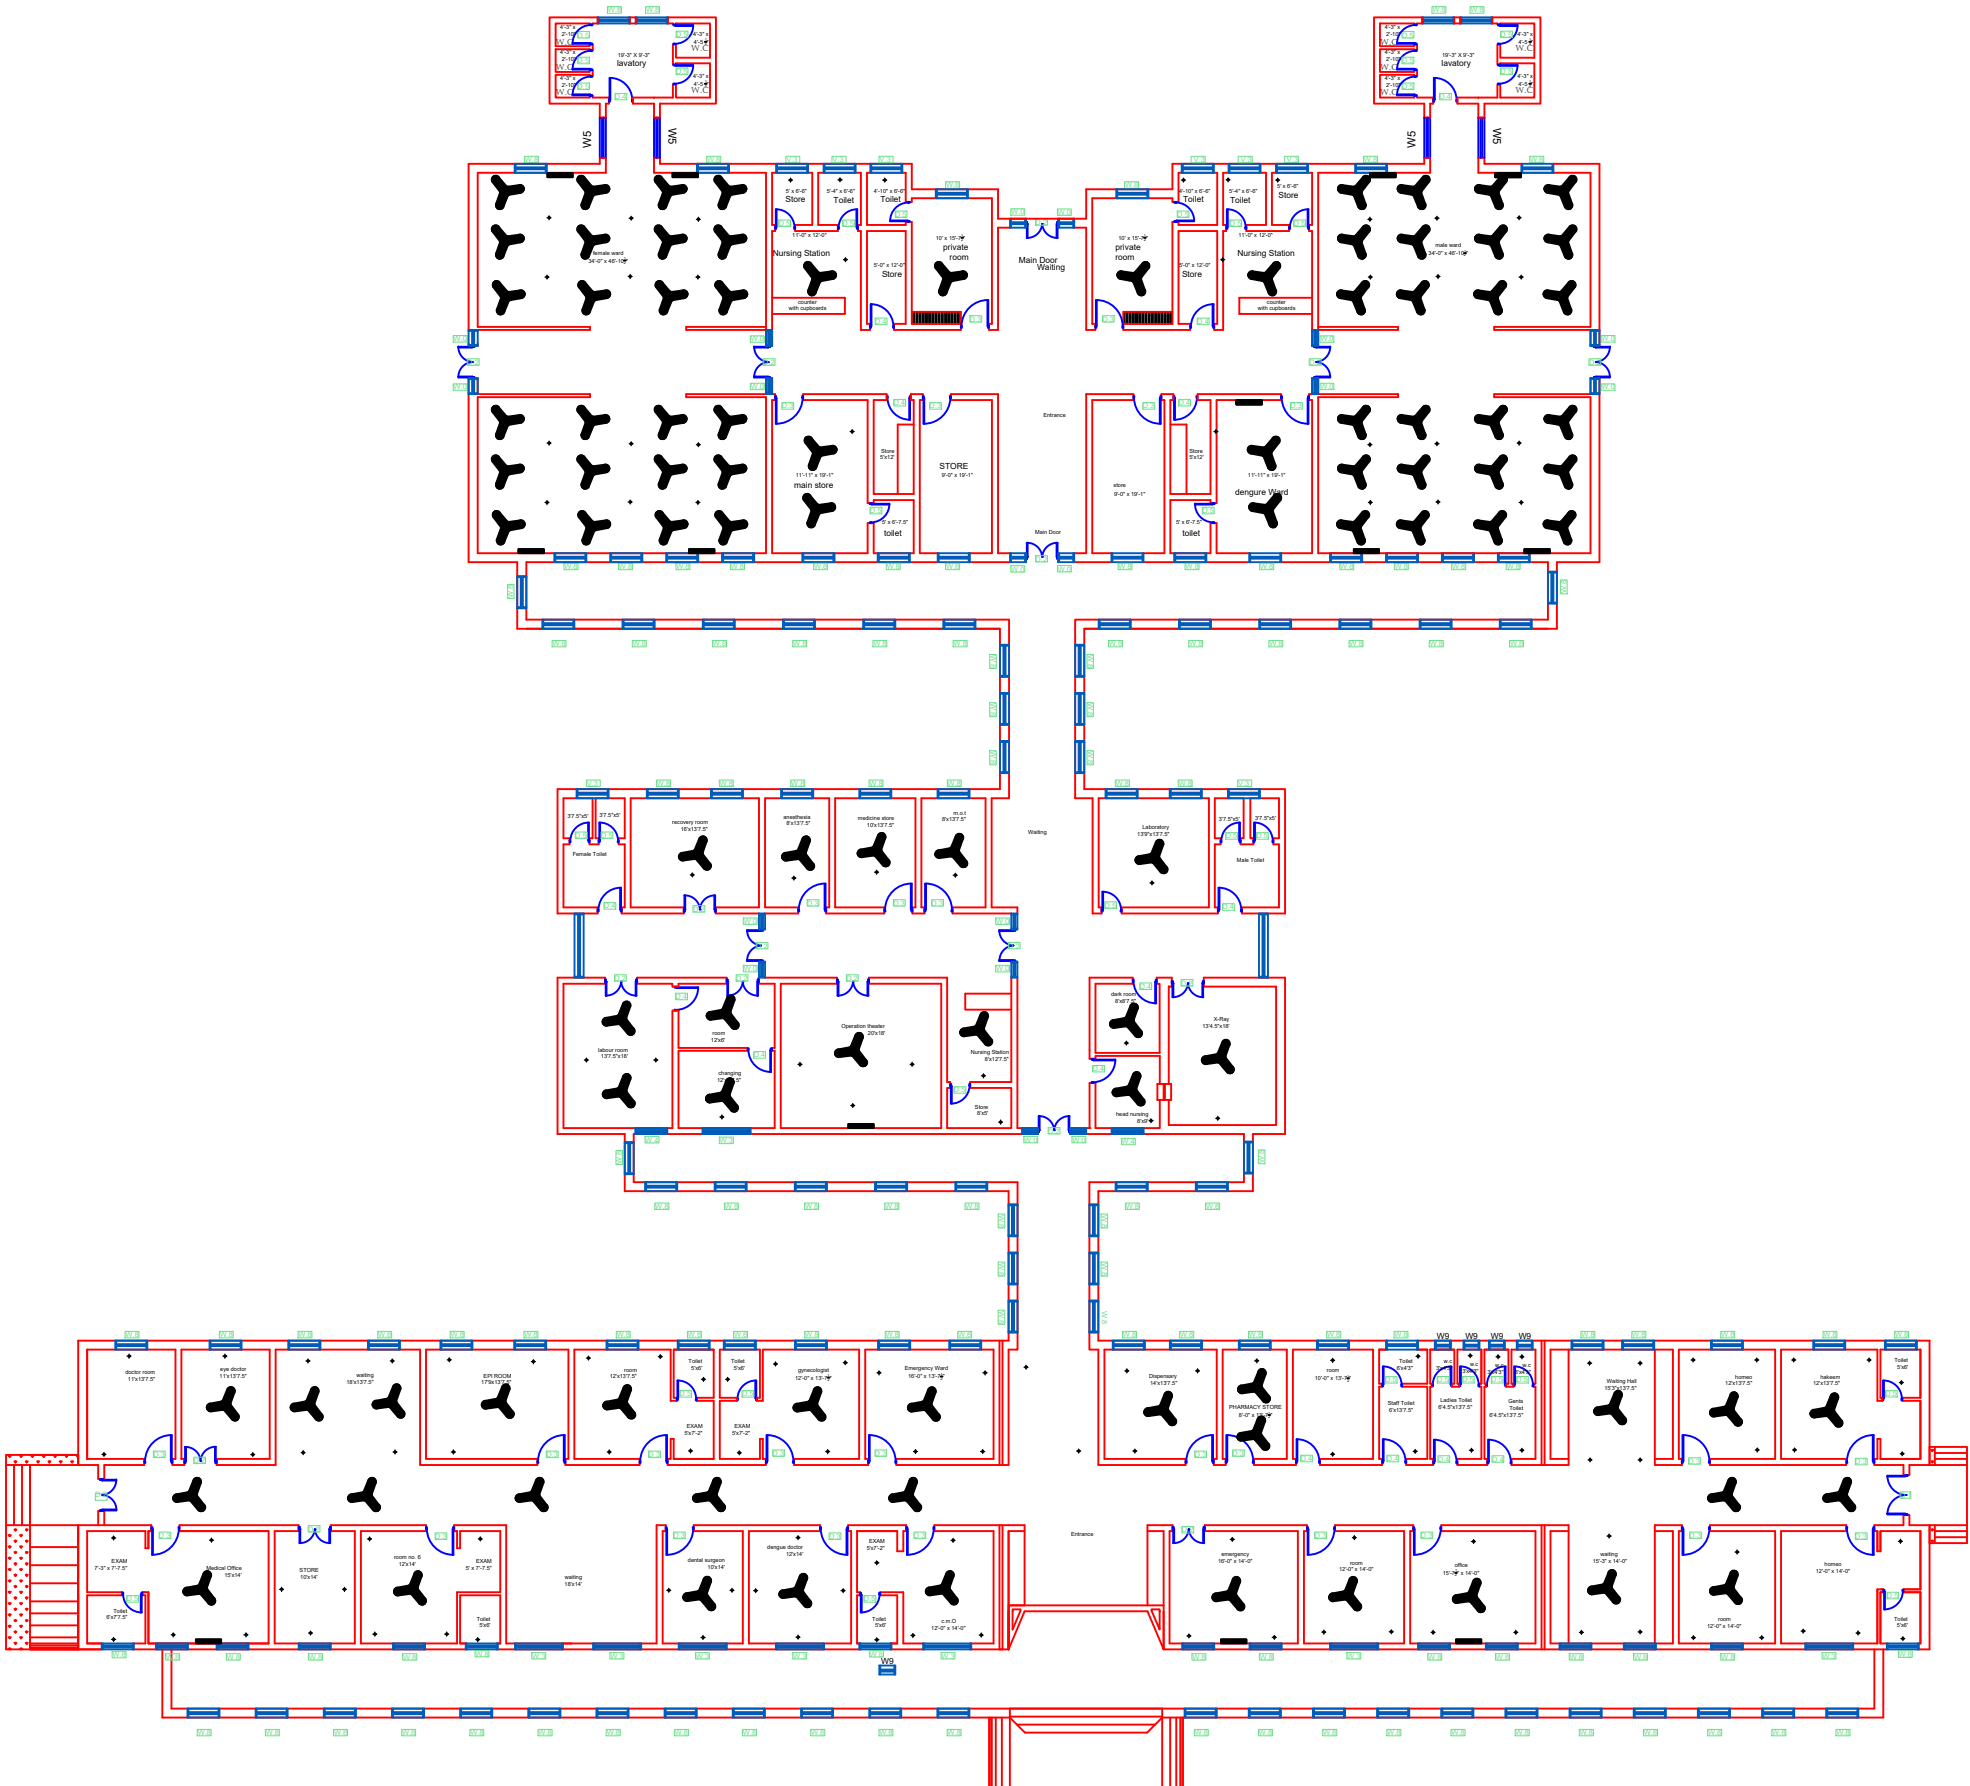

Legends:

Residential Area

Road

Wall

Power Line

OHT

Tree

Man Hole

Tube Well

Light Pole

Lawns

Earthen Areas

Asphalts Roads

Tough Pavers

P.C.C / Plinth Protection

Boundary Wall

Brick Pavers / Soling

Drain

Tap

Hand Pump

Air Conditioner

Tube Light

Fan

Roof Light

Bulb

AREA

AREA WITHIN BOUNDARY WALL

350102.606 Sft

AREA OF CLINICAL BLOCK

24511.362 Sft

PLINTH AREA OF BLOCK

24511.362 Sft

OPENING SCHEDULE OF DOORS AND WINDOWS

DOORS	WIDTH	HEIGHT	WINDOWS	WIDTH	HEIGHT
D1	5'-6"	7'-0"	W1	3'-0"	3'-0"
D2	5'-0"	7'-0"	W2	3'-6"	3'-6"
D3	4'-0"	7'-0"	W3	6'-0"	6'-0"
D4	3'-6"	7'-0"	W4	4'-6"	4'-6"
D5	3'-0"	7'-0"	W5	8'-6"	8'-6"
D6	2'-6"	7'-0"	W6	2'-6"	2'-6"
D7	6'-0"	7'-0"	W7	4'-0"	4'-0"
V1	1'-6"	1'-6"	W8	5'-0"	5'-0"
V2	2'-0"	2'-0"	W9	2'-0"	2'-0"

Project:

CAD MAPPING OF TEHSIL HEAD QUARTER HOSPITALS, PUNJAB

Client:

GOVERNMENT OF THE PUNJAB
PRIMARY & SECONDARY
HEALTHCARE DEPARTMENT

Consultant:

SKAFS CONSULTANT (Pvt.) Limited
ENGINEERING AND ENVIRONMENT
CONSULTANT

Drawing Title:

THQ JAND
ELECTRICAL PLAN (GROUND FLOOR)

Drawing No.

SKAFS/JAND /13