

# PART 1


## PART 2

## PART 3

---

---

# PART 4

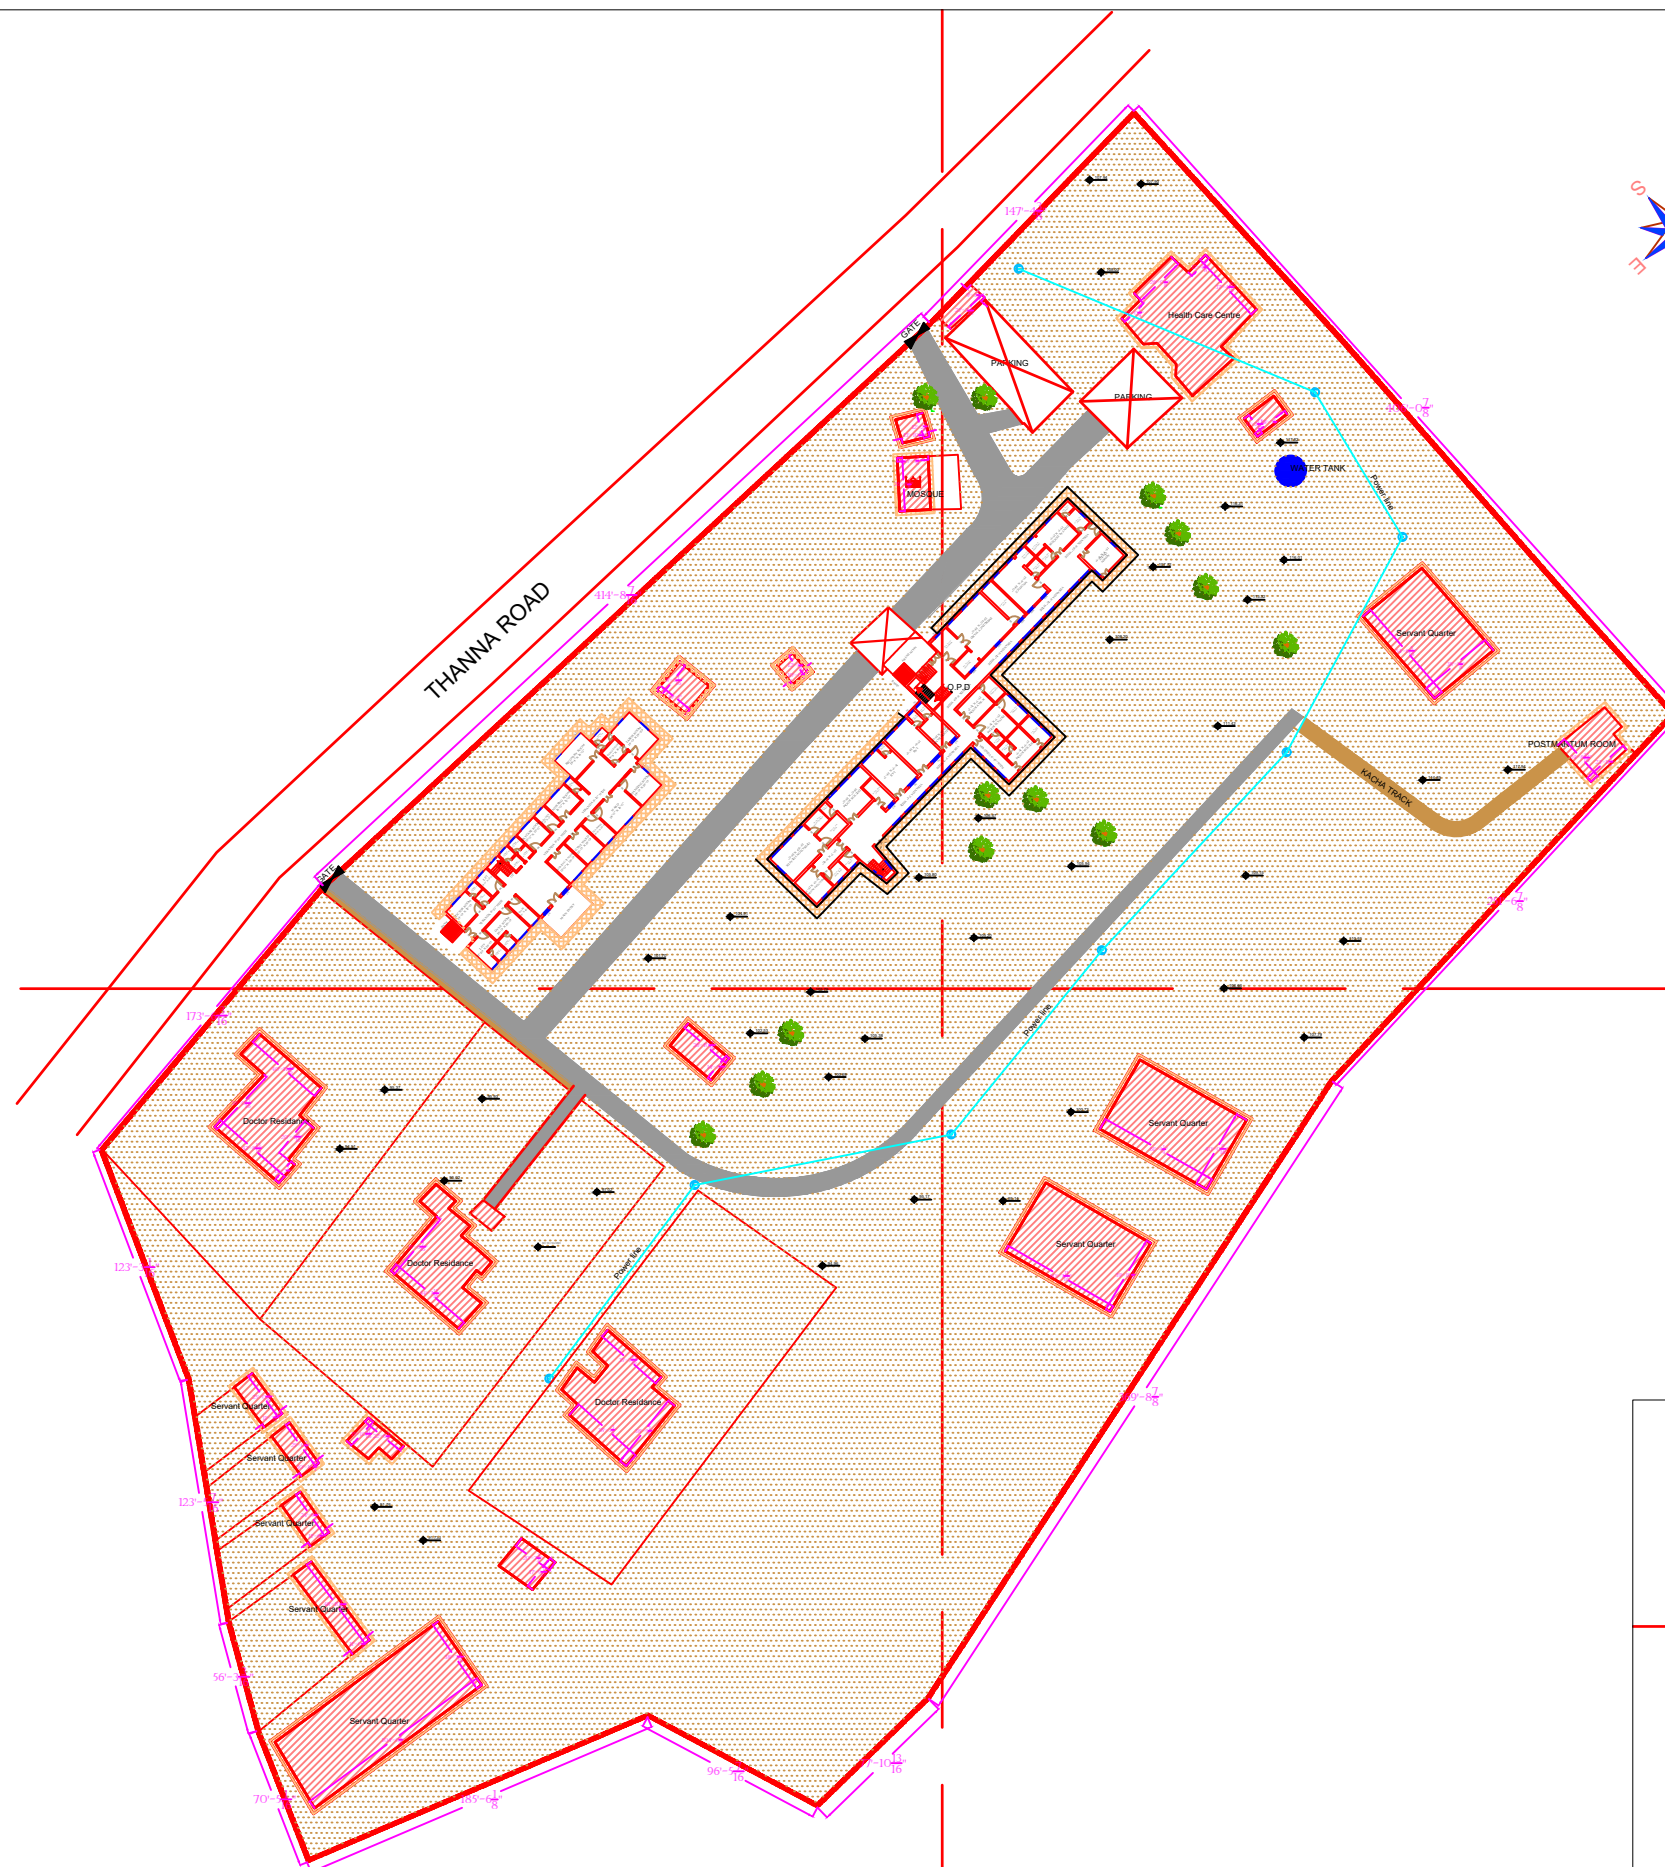

| Legends:              |                                                                                       |
|-----------------------|---------------------------------------------------------------------------------------|
| RESIDENTIAL AREA      |    |
| ROAD                  |    |
| WALL                  |    |
| POWER LINE            |    |
| OHT                   |    |
| TREE                  |    |
| MAN HOLE              |    |
| TUBE WELL             |    |
| LIGHT POLE            |    |
| LAWNS                 |    |
| EARTHEN AREAS         |    |
| ASPHALTS ROADS        |    |
| TOUGH PAVERS          |    |
| P.C.C / PLINTH        |    |
| BOUNDARY WALL         |    |
| BRICK PAVERS / SOLING |    |
| DRAIN                 |    |
| TAP                   |    |
| HAND PUMP             |  |
| AIR CONDITIONER       |  |
| TUBE LIGHT            |  |
| FAN                   |  |
| ROOF LIGHT            |  |
| BULB                  |  |

| AREA                      |                |
|---------------------------|----------------|
| AREA WITHIN BOUNDARY WALL | 353881.381 SFT |
| AREA OF CLINICAL BLOCK    | 26815.531 SFT  |
| PLINTH AREA OF BLOCK      | 15832.795 SFT  |


| OPENING SCHEDULE OF DOORS AND WINDOWS |       |        |         |       |        |
|---------------------------------------|-------|--------|---------|-------|--------|
| DOORS                                 | WIDTH | HEIGHT | WINDOWS | WIDTH | HEIGHT |
| D1                                    | 2'-0" | 7'-0"  | W1      | 3'-0" | 5'-0"  |
| D2                                    | 2'-6" | 7'-0"  | W2      | 4'-0" | 4'-0"  |
| D3                                    | 3'-0" | 7'-0"  | W3      | 6'-0" | 6'-0"  |
| D4                                    | 3'-6" | 7'-0"  | W4      | 8'-0" | 8'-0"  |
| D5                                    | 4'-0" | 7'-0"  | W5      | 5'-0" | 5'-0"  |
| D6                                    | 4'-6" | 7'-0"  | W6      |       |        |
| D7                                    | 5'-0" | 7'-0"  | W7      |       |        |
| D8                                    | 6'-0" | 7'-0"  | V1      | 2'-0" | 2'-0"  |
| D9                                    | 7'-0" | 7'-0"  | V2      |       |        |

Project:  
**CAD MAPPING OF TEHSIL  
HEAD QUARTER HOSPITALS,  
PUNJAB**

|                                                                                                                                                                                                          |                                                                                                                                                                                                                         |
|----------------------------------------------------------------------------------------------------------------------------------------------------------------------------------------------------------|-------------------------------------------------------------------------------------------------------------------------------------------------------------------------------------------------------------------------|
| <p><b>Client:</b></p>  <p>GOVERNMENT OF THE PUNJAB<br/><b>PRIMARY &amp; SECONDARY<br/>HEALTHCARE DEPARTMENT</b></p> | <p><b>Consultant:</b></p>  <p><b>SKAFS CONSULTANT (Pvt.)<br/>Limited</b><br/><i>ENGINEERING AND ENVIRONMENT<br/>CONSULTANT</i></p> |
|----------------------------------------------------------------------------------------------------------------------------------------------------------------------------------------------------------|-------------------------------------------------------------------------------------------------------------------------------------------------------------------------------------------------------------------------|


Drawing Title: **THQ KAHUTA  
HOSPITAL MASTER PLAN**

Drawing No. **SKAFS/KAHUTA /03**

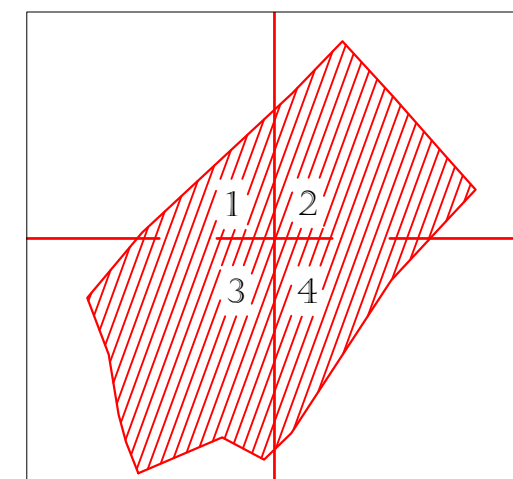

# MASTER PLAN OF THQ HOSPITAL KAHUTA

## PART 1

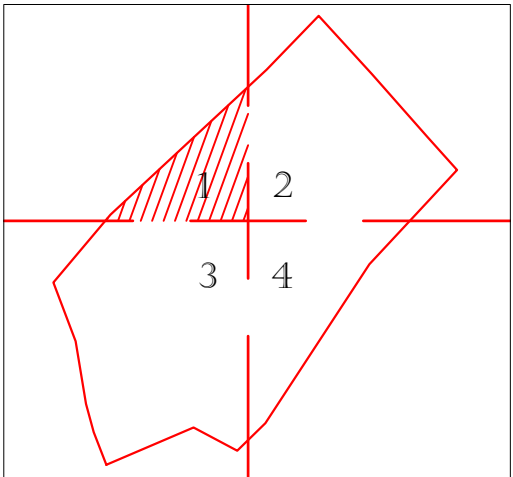

**Legends:**

|                       |  |
|-----------------------|--|
| RESIDENTIAL AREA      |  |
| ROAD                  |  |
| WALL                  |  |
| POWER LINE            |  |
| OHT                   |  |
| TREE                  |  |
| MAN HOLE              |  |
| TUBE WELL             |  |
| LIGHT POLE            |  |
| LAWNS                 |  |
| EARTHEN AREAS         |  |
| ASPHALTS ROADS        |  |
| TOUGH PAVERS          |  |
| P.C.C / PLINTH        |  |
| BOUNDARY WALL         |  |
| BRICK PAVERS / SOLING |  |
| DRAIN                 |  |
| TAP                   |  |
| HAND PUMP             |  |
| AIR CONDITIONER       |  |
| TUBE LIGHT            |  |
| FAN                   |  |
| ROOF LIGHT            |  |
| BULB                  |  |

| AREA                      |                |
|---------------------------|----------------|
| AREA WITHIN BOUNDARY WALL | 353881.381 SFT |
| AREA OF CLINICAL BLOCK    | 26815.531 SFT  |
| PLINTH AREA OF BLOCK      | 15832.795 SFT  |

| OPENING SCHEDULE OF DOORS AND WINDOWS |       |        |         |       |        |
|---------------------------------------|-------|--------|---------|-------|--------|
| DOORS                                 | WIDTH | HEIGHT | WINDOWS | WIDTH | HEIGHT |
| D1                                    | 2'-0" | 7'-0"  | W1      | 3'-0" | 5'-0"  |
| D2                                    | 2'-6" | 7'-0"  | W2      | 4'-0" | 4'-0"  |
| D3                                    | 3'-0" | 7'-0"  | W3      | 6'-0" | 6'-0"  |
| D4                                    | 3'-6" | 7'-0"  | W4      | 8'-0" | 8'-0"  |
| D5                                    | 4'-0" | 7'-0"  | W5      | 5'-0" | 5'-0"  |
| D6                                    | 4'-6" | 7'-0"  | W6      |       |        |
| D7                                    | 5'-0" | 7'-0"  | W7      |       |        |
| D8                                    | 6'-0" | 7'-0"  | V1      | 2'-0" | 2'-0"  |
| D9                                    | 7'-0" | 7'-0"  | V2      |       |        |

Project:  
**CAD MAPPING OF TEHSIL HEAD QUARTER HOSPITALS, PUNJAB**

Client:

GOVERNMENT OF THE PUNJAB  
PRIMARY & SECONDARY  
HEALTHCARE DEPARTMENT

Consultant:



SKAFS CONSULTANT (Pvt.)  
Limited  
ENGINEERING AND ENVIRONMENT  
CONSULTANT

Drawing Title: **THQ KAHUTA HOSPITAL MASTER PLAN PART 1**

Drawing No. **SKAFS/KAHUTA /04**

# MASTER PLAN OF THQ HOSPITAL KAHUTA

## PART 2

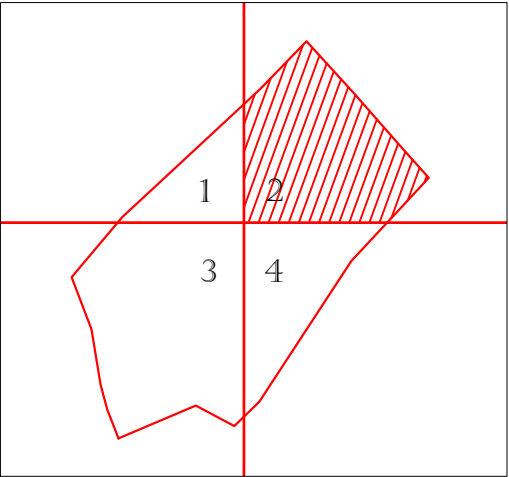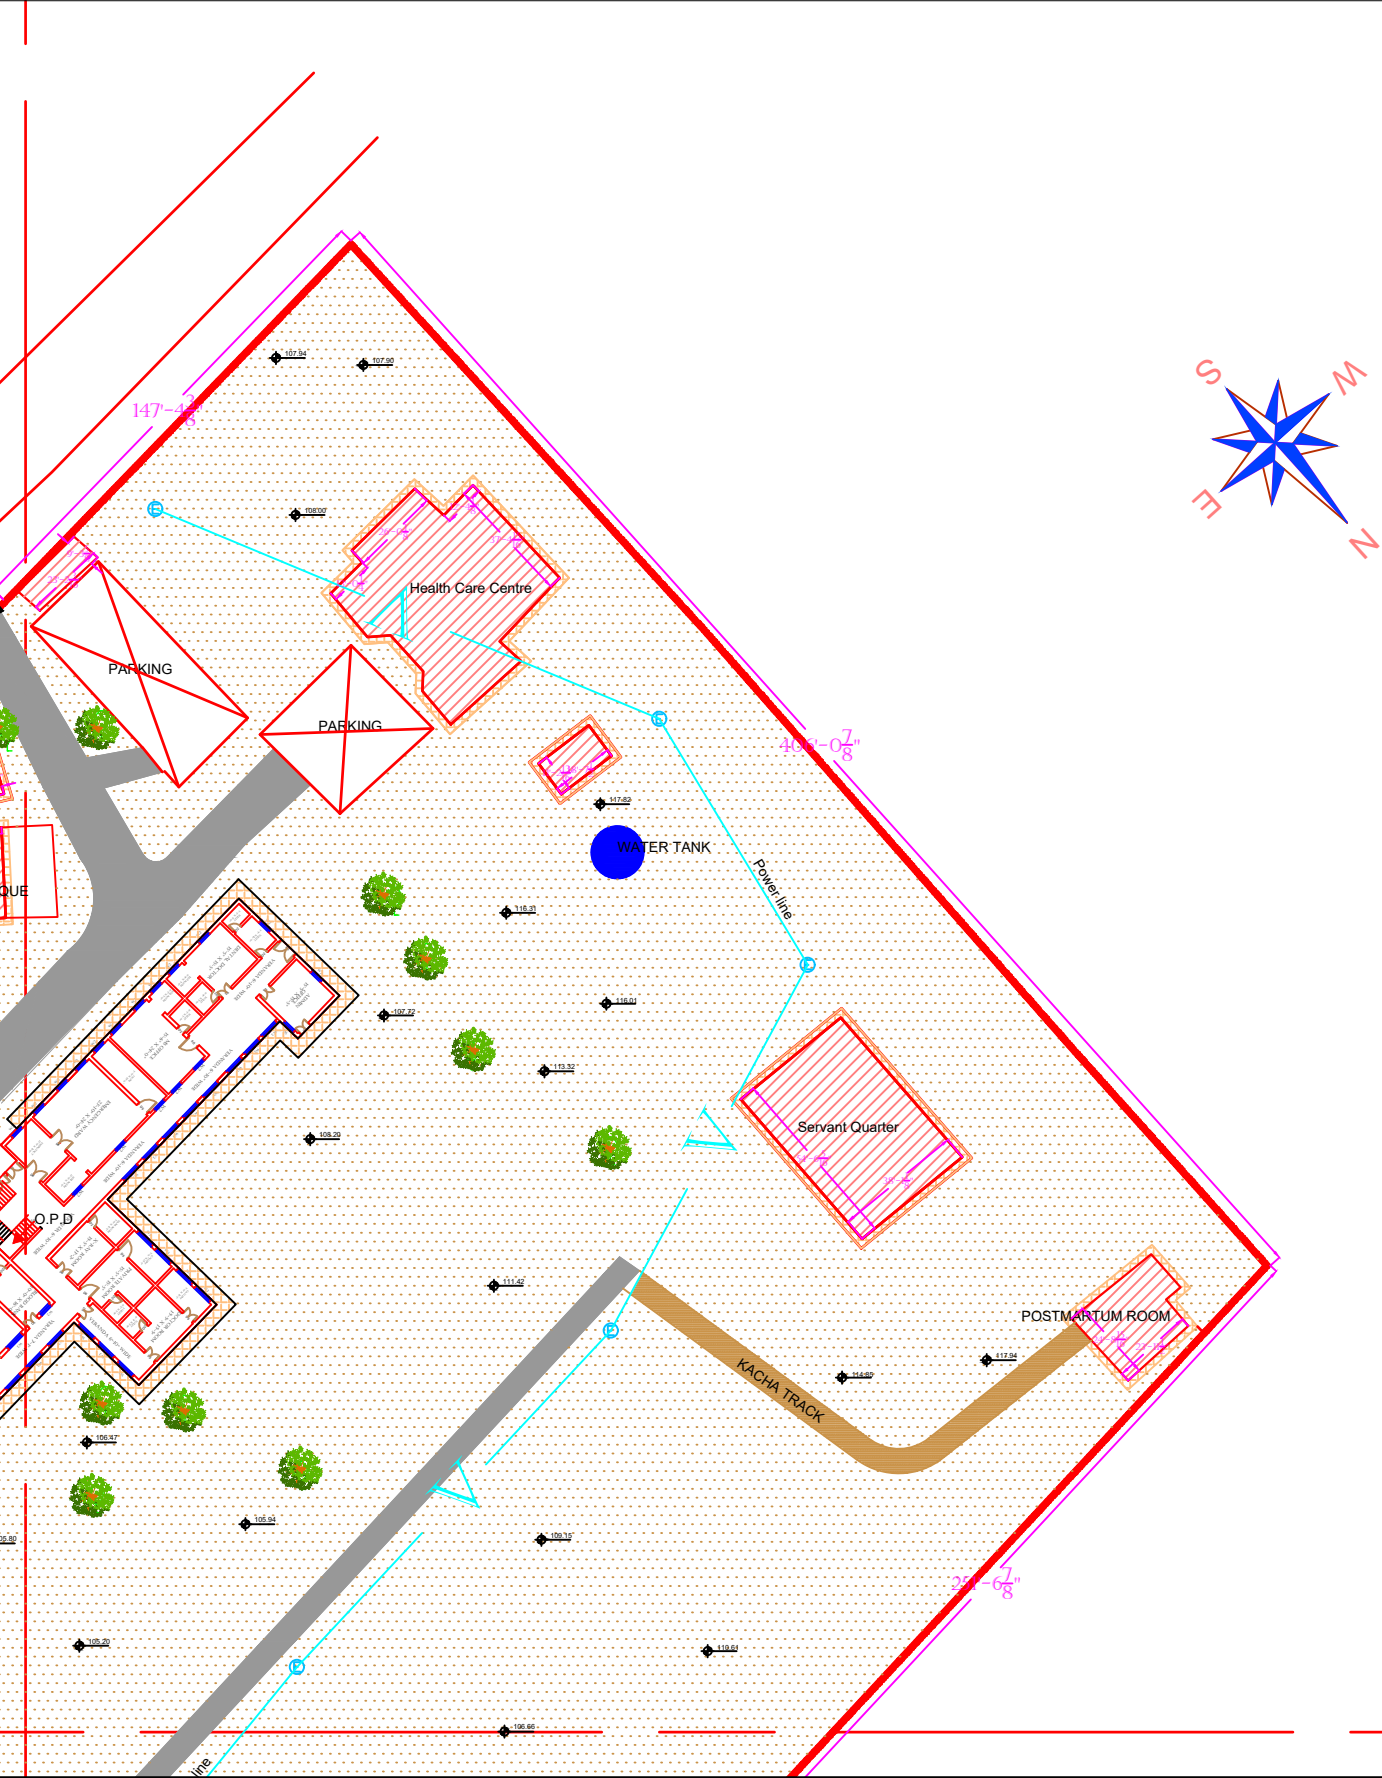

**Legends:**

|                       |  |
|-----------------------|--|
| RESIDENTIAL AREA      |  |
| ROAD                  |  |
| WALL                  |  |
| POWER LINE            |  |
| OHT                   |  |
| TREE                  |  |
| MAN HOLE              |  |
| TUBE WELL             |  |
| LIGHT POLE            |  |
| LAWNS                 |  |
| EARTHEN AREAS         |  |
| ASPHALTS ROADS        |  |
| TOUGH PAVERS          |  |
| P.C.C / PLINTH        |  |
| BOUNDARY WALL         |  |
| BRICK PAVERS / SOLING |  |
| DRAIN                 |  |
| TAP                   |  |
| HAND PUMP             |  |
| AIR CONDITIONER       |  |
| TUBE LIGHT            |  |
| FAN                   |  |
| ROOF LIGHT            |  |
| BULB                  |  |

| AREA                      |                |
|---------------------------|----------------|
| AREA WITHIN BOUNDARY WALL | 353881.381 SFT |
| AREA OF CLINICAL BLOCK    | 26815.531 SFT  |
| PLINTH AREA OF BLOCK      | 15832.795 SFT  |

| OPENING SCHEDULE OF DOORS AND WINDOWS |       |        |         |       |        |
|---------------------------------------|-------|--------|---------|-------|--------|
| DOORS                                 | WIDTH | HEIGHT | WINDOWS | WIDTH | HEIGHT |
| D1                                    | 2'-0" | 7'-0"  | W1      | 3'-0" | 5'-0"  |
| D2                                    | 2'-6" | 7'-0"  | W2      | 4'-0" | 4'-0"  |
| D3                                    | 3'-0" | 7'-0"  | W3      | 6'-0" | 6'-0"  |
| D4                                    | 3'-6" | 7'-0"  | W4      | 8'-0" | 8'-0"  |
| D5                                    | 4'-0" | 7'-0"  | W5      | 5'-0" | 5'-0"  |
| D6                                    | 4'-6" | 7'-0"  | W6      |       |        |
| D7                                    | 5'-0" | 7'-0"  | W7      |       |        |
| D8                                    | 6'-0" | 7'-0"  | V1      | 2'-0" | 2'-0"  |
| D9                                    | 7'-0" | 7'-0"  | V2      |       |        |

Project:

**CAD MAPPING OF TEHSIL HEAD QUARTER HOSPITALS, PUNJAB**

Client:

GOVERNMENT OF THE PUNJAB  
PRIMARY & SECONDARY  
HEALTHCARE DEPARTMENT

Consultant:

SKAFS CONSULTANT (Pvt.)  
Limited  
ENGINEERING AND ENVIRONMENT  
CONSULTANT



Drawing Title: **THQ KAHUTA HOSPITAL MASTER PLAN PART 2**

Drawing No. **SKAFS/KAHUTA /05**



# MASTER PLAN OF THQ HOSPITAL KAHUTA

## PART 3

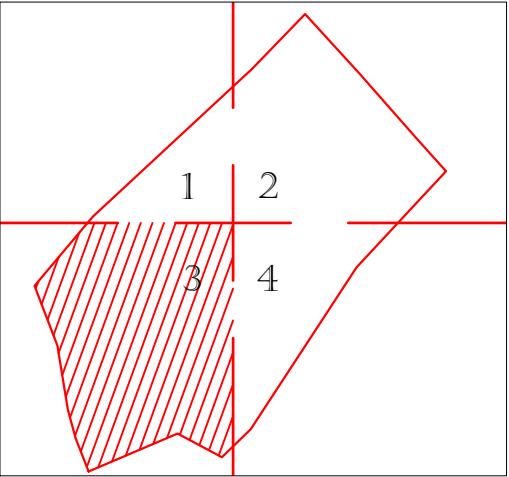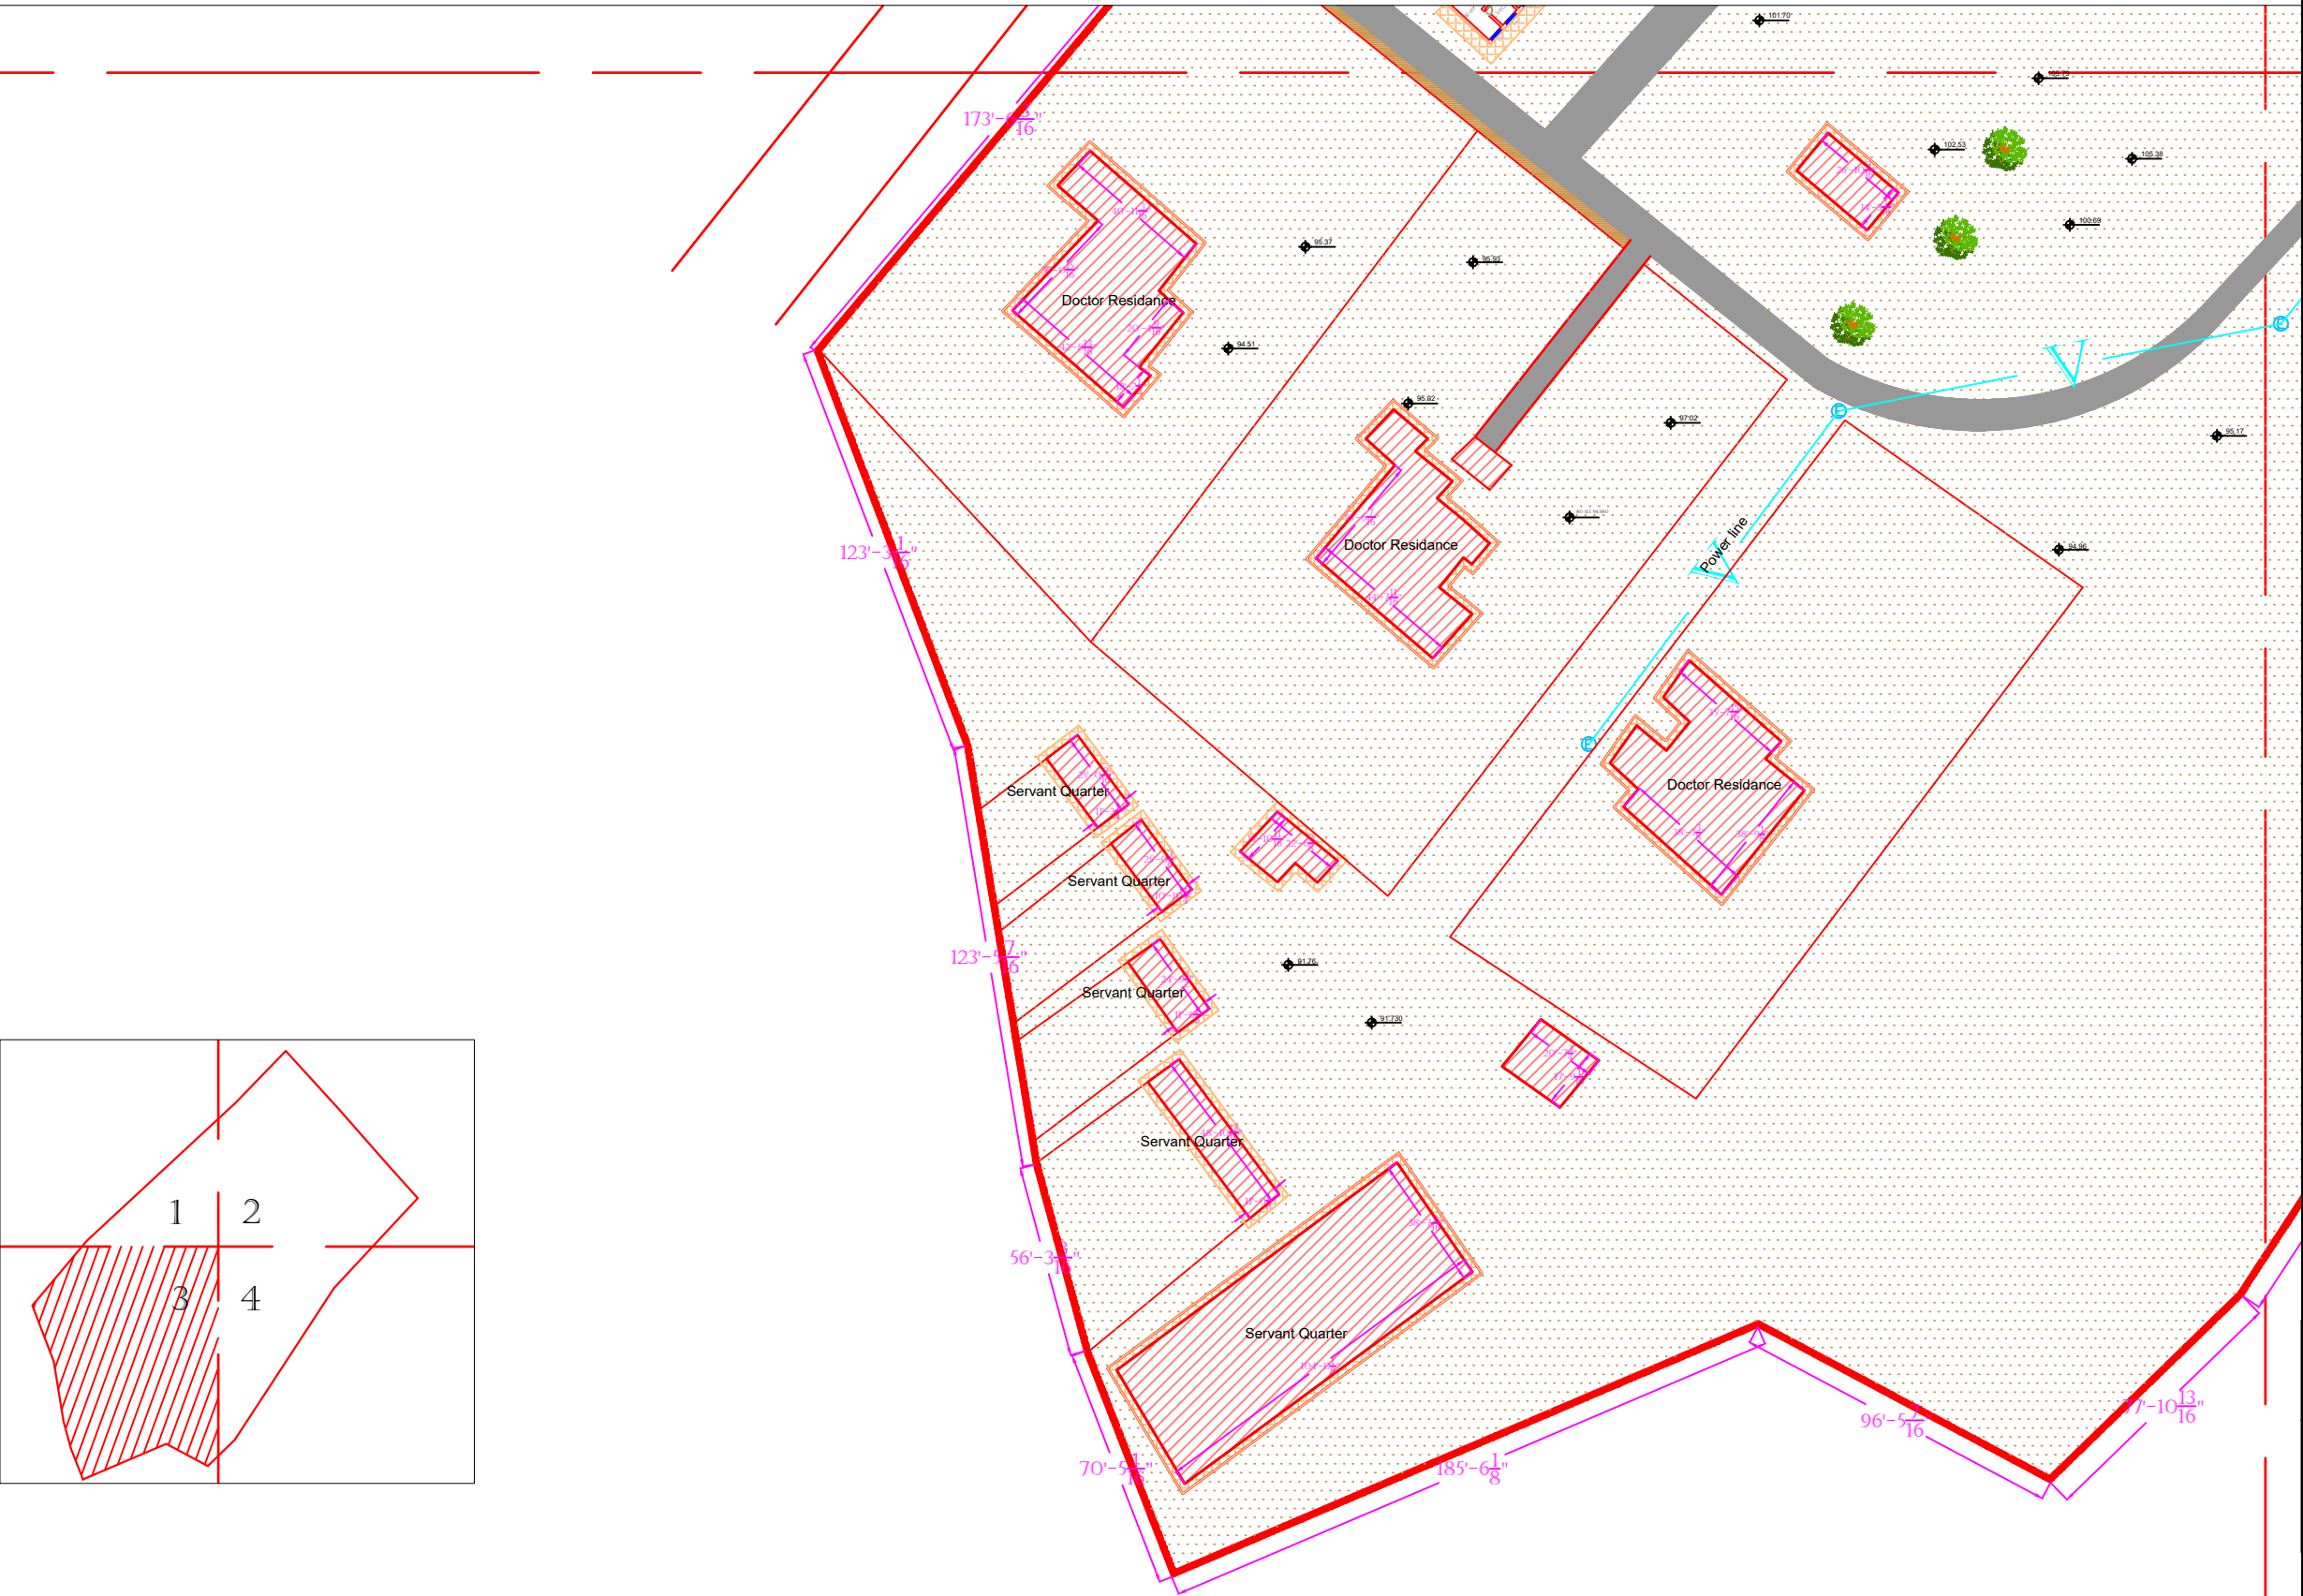

**Legends:**

|                       |  |
|-----------------------|--|
| RESIDENTIAL AREA      |  |
| ROAD                  |  |
| WALL                  |  |
| POWER LINE            |  |
| OHT                   |  |
| TREE                  |  |
| MAN HOLE              |  |
| TUBE WELL             |  |
| LIGHT POLE            |  |
| LAWNS                 |  |
| EARTHEN AREAS         |  |
| ASPHALTS ROADS        |  |
| TOUGH PAVERS          |  |
| P.C.C / PLINTH        |  |
| BOUNDARY WALL         |  |
| BRICK PAVERS / SOLING |  |
| DRAIN                 |  |
| TAP                   |  |
| HAND PUMP             |  |
| AIR CONDITIONER       |  |
| TUBE LIGHT            |  |
| FAN                   |  |
| ROOF LIGHT            |  |
| BULB                  |  |

| AREA                      |                |
|---------------------------|----------------|
| AREA WITHIN BOUNDARY WALL | 353881.381 SFT |
| AREA OF CLINICAL BLOCK    | 26815.531 SFT  |
| PLINTH AREA OF BLOCK      | 15832.795 SFT  |

| OPENING SCHEDULE OF DOORS AND WINDOWS |       |        |         |       |        |
|---------------------------------------|-------|--------|---------|-------|--------|
| DOORS                                 | WIDTH | HEIGHT | WINDOWS | WIDTH | HEIGHT |
| D1                                    | 2'-0" | 7'-0"  | W1      | 3'-0" | 5'-0"  |
| D2                                    | 2'-6" | 7'-0"  | W2      | 4'-0" | 4'-0"  |
| D3                                    | 3'-0" | 7'-0"  | W3      | 6'-0" | 6'-0"  |
| D4                                    | 3'-6" | 7'-0"  | W4      | 8'-0" | 8'-0"  |
| D5                                    | 4'-0" | 7'-0"  | W5      | 5'-0" | 5'-0"  |
| D6                                    | 4'-6" | 7'-0"  | W6      |       |        |
| D7                                    | 5'-0" | 7'-0"  | W7      |       |        |
| D8                                    | 6'-0" | 7'-0"  | V1      | 2'-0" | 2'-0"  |
| D9                                    | 7'-0" | 7'-0"  | V2      |       |        |



Project:  
**CAD MAPPING OF TEHSIL HEAD QUARTER HOSPITALS, PUNJAB**

|                                                                                         |                                                                                              |
|-----------------------------------------------------------------------------------------|----------------------------------------------------------------------------------------------|
| Client:<br><br>GOVERNMENT OF THE PUNJAB<br>PRIMARY & SECONDARY<br>HEALTHCARE DEPARTMENT | Consultant:<br><br>SKAFS CONSULTANT (Pvt.) Limited<br>ENGINEERING AND ENVIRONMENT CONSULTANT |
|-----------------------------------------------------------------------------------------|----------------------------------------------------------------------------------------------|

Drawing Title:  
**THQ KAHUTA HOSPITAL MASTER PLAN PART 3**

Drawing No.  
**SKAFS/KAHUTA /06**

MASTER PLAN OF THQ HOSPITAL KAHUTA  
PART 4

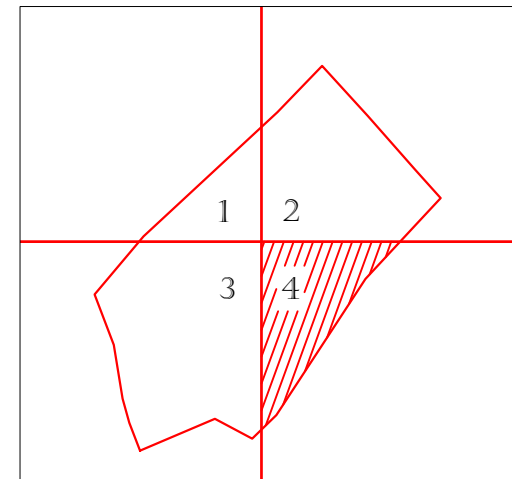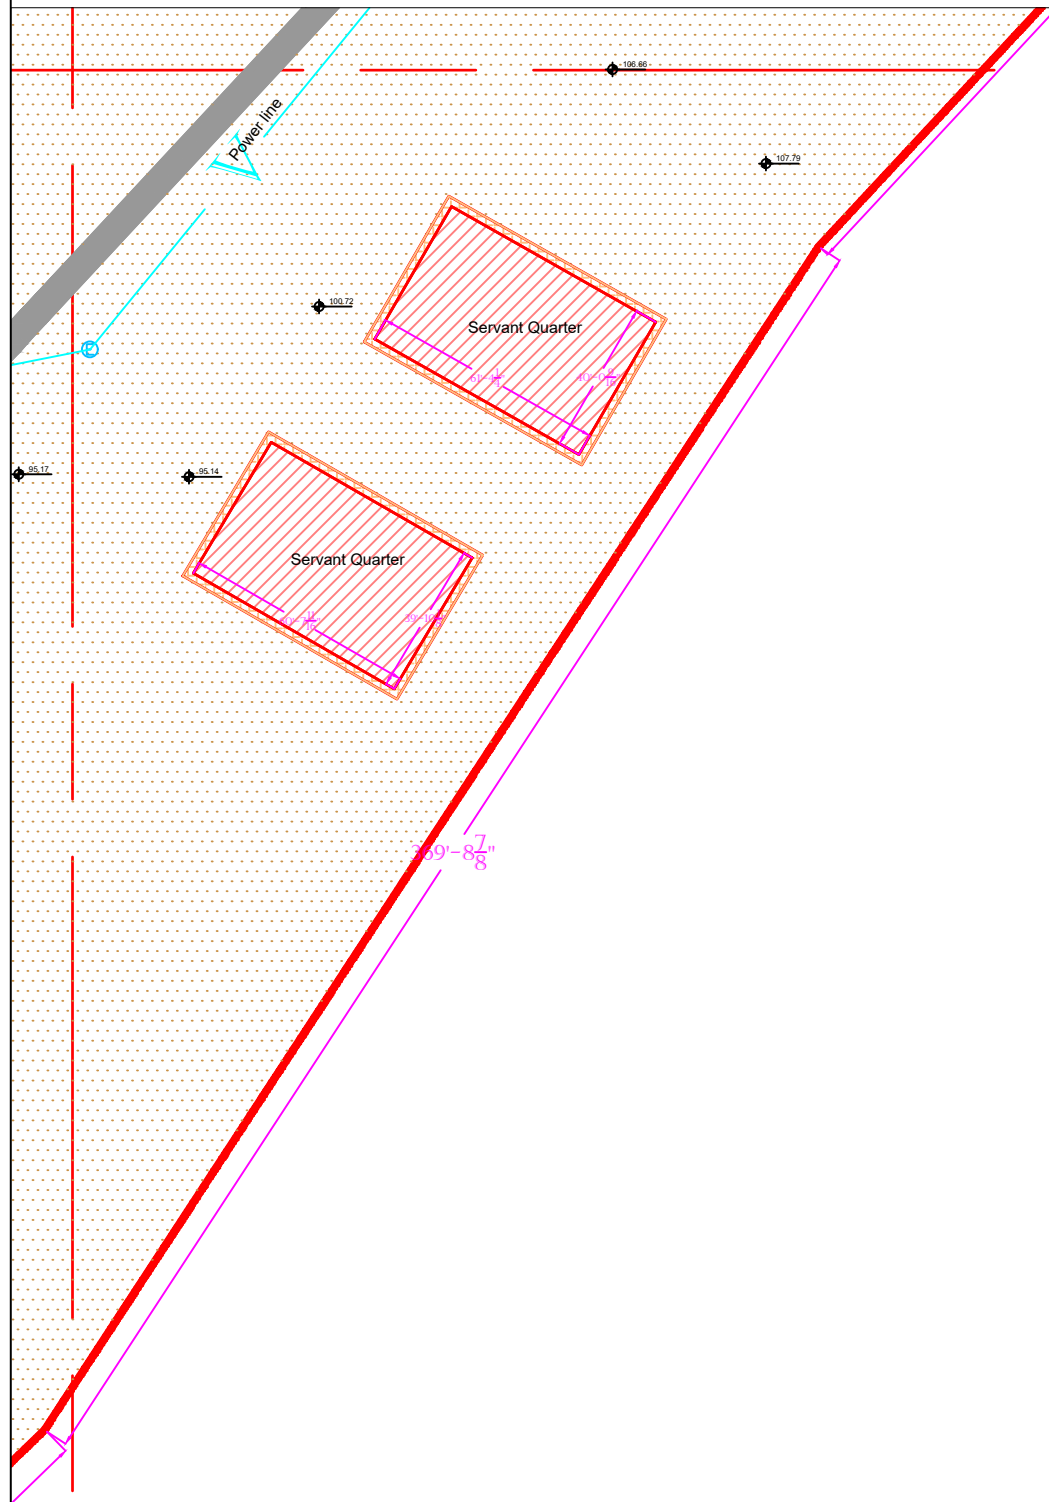

| Legends:              |                                                                                       |
|-----------------------|---------------------------------------------------------------------------------------|
| RESIDENTIAL           |    |
| AREA ROAD             |    |
| WALL                  |    |
| POWER LINE            |    |
| OHT                   |    |
| TREE                  |    |
| MAN HOLE              |    |
| TUBE WELL             |    |
| LIGHT POLE            |    |
| LAWNS                 |    |
| EARTHEN AREAS         |    |
| ASPHALTS ROADS        |    |
| TOUGH PAVERS          |    |
| P.C.C / PLINTH        |    |
| BOUNDARY WALL         |    |
| BRICK PAVERS / SOLING |   |
| DRAIN                 |  |
| TAP                   |  |
| HAND PUMP             |  |
| AIR CONDITIONER       |  |
| TUBE LIGHT            |  |
| FAN                   |  |
| ROOF LIGHT            |  |
| BULB                  |  |

| AREA                      |                |
|---------------------------|----------------|
| AREA WITHIN BOUNDARY WALL | 353881.381 SFT |
| AREA OF CLINICAL BLOCK    | 26815.531 SFT  |
| PLINTH AREA OF BLOCK      | 15832.795 SFT  |

| OPENING SCHEDULE OF DOORS AND WINDOWS |       |        |         |       |        |
|---------------------------------------|-------|--------|---------|-------|--------|
| DOORS                                 | WIDTH | HEIGHT | WINDOWS | WIDTH | HEIGHT |
| D1                                    | 2'-0" | 7'-0"  | W1      | 3'-0" | 5'-0"  |
| D2                                    | 2'-6" | 7'-0"  | W2      | 4'-0" | 4'-0"  |
| D3                                    | 3'-0" | 7'-0"  | W3      | 6'-0" | 6'-0"  |
| D4                                    | 3'-6" | 7'-0"  | W4      | 8'-0" | 8'-0"  |
| D5                                    | 4'-0" | 7'-0"  | W5      | 5'-0" | 5'-0"  |
| D6                                    | 4'-6" | 7'-0"  | W6      |       |        |
| D7                                    | 5'-0" | 7'-0"  | W7      |       |        |
| D8                                    | 6'-0" | 7'-0"  | V1      | 2'-0" | 2'-0"  |
| D9                                    | 7'-0" | 7'-0"  | V2      |       |        |

Project:  
**CAD MAPPING OF TEHSIL  
HEAD QUARTER HOSPITALS,  
PUNJAB**

|                                                                                                                                                                                                          |                                                                                                                                                                                                                         |
|----------------------------------------------------------------------------------------------------------------------------------------------------------------------------------------------------------|-------------------------------------------------------------------------------------------------------------------------------------------------------------------------------------------------------------------------|
| <p><b>Client:</b></p>  <p><b>GOVERNMENT OF THE PUNJAB<br/>PRIMARY &amp; SECONDARY<br/>HEALTHCARE DEPARTMENT</b></p> | <p><b>Consultant:</b></p>  <p><b>SKAFS CONSULTANT (Pvt.)<br/>Limited</b><br/><i>ENGINEERING AND ENVIRONMENT<br/>CONSULTANT</i></p> |
|----------------------------------------------------------------------------------------------------------------------------------------------------------------------------------------------------------|-------------------------------------------------------------------------------------------------------------------------------------------------------------------------------------------------------------------------|

|                |                                                   |
|----------------|---------------------------------------------------|
| Drawing Title: | <b>THQ KAHUTA<br/>HOSPITAL MASTER PLAN PART 4</b> |
|----------------|---------------------------------------------------|


Drawing No. **SKAFS/KAHUTA /07**

# CLINICAL BLOCK OF THQ HOSPITAL KAHUTA

## GROUND FLOOR

PART 1


PART 2

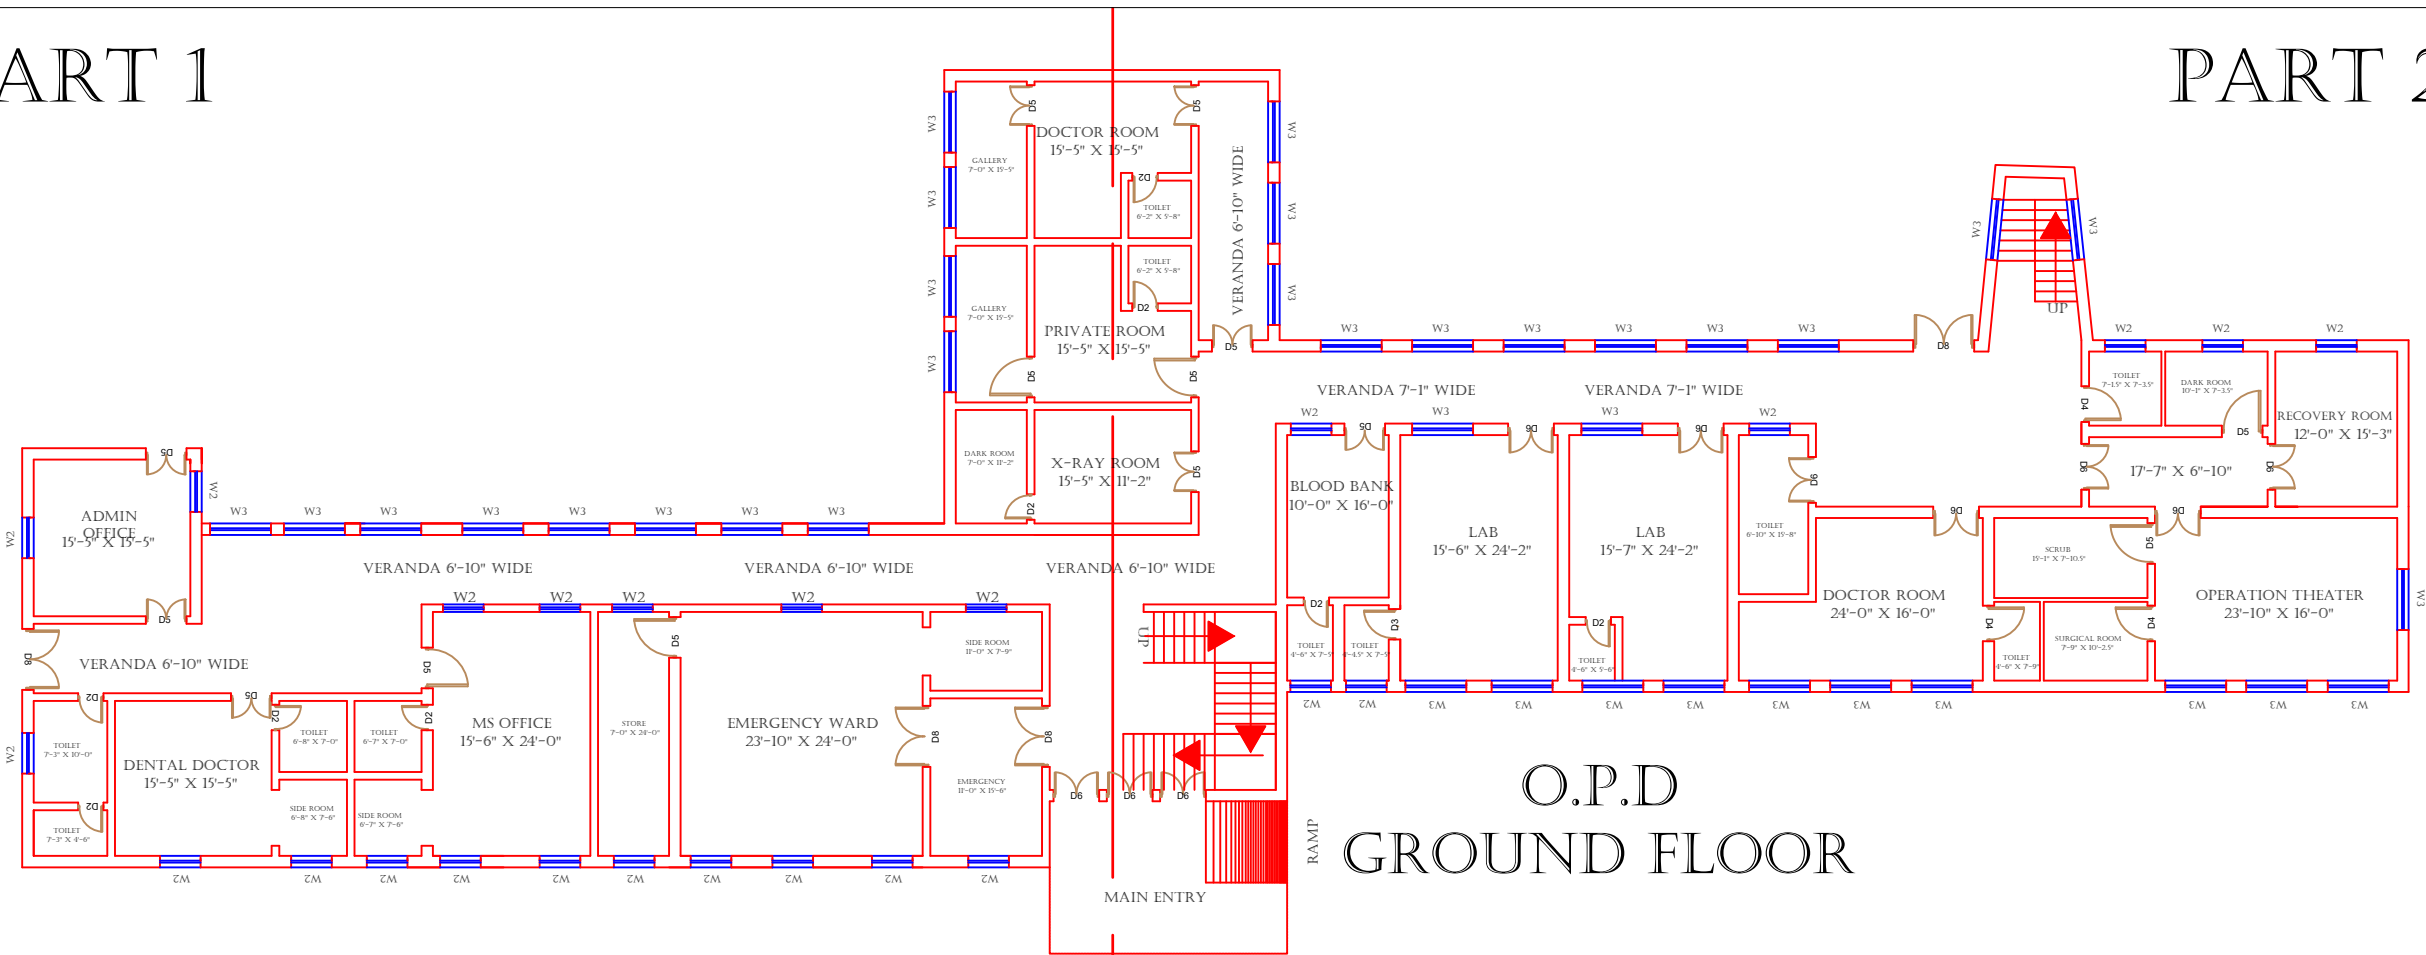

O.P.D  
GROUND FLOOR

PART 3

PART 4

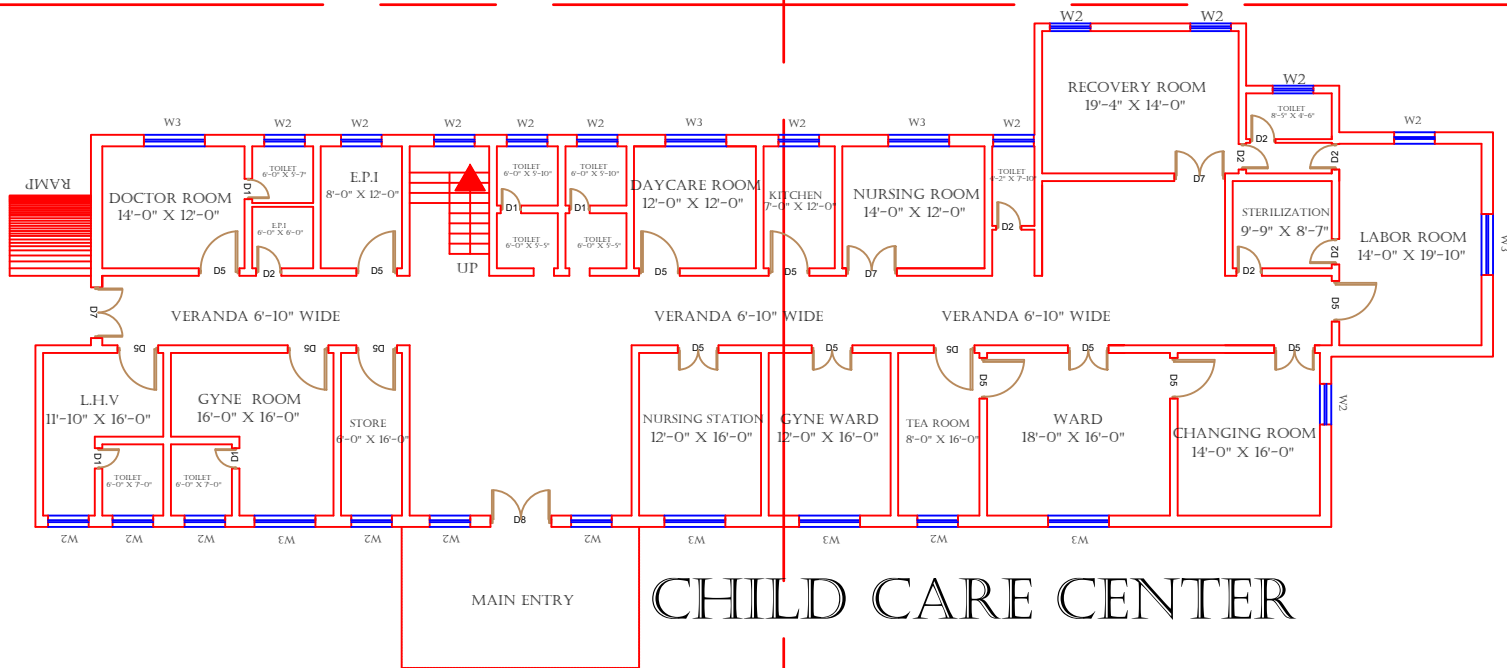

CHILD CARE CENTER

### Legends:

|                       |  |
|-----------------------|--|
| RESIDENTIAL AREA      |  |
| ROAD                  |  |
| WALL                  |  |
| POWER LINE            |  |
| OHT                   |  |
| TREE                  |  |
| MAN HOLE              |  |
| TUBE WELL             |  |
| LIGHT POLE            |  |
| LAWNS                 |  |
| EARTHEN AREAS         |  |
| ASPHALTS ROADS        |  |
| TOUGH PAVERS          |  |
| P.C.C / PLINTH        |  |
| BOUNDARY WALL         |  |
| BRICK PAVERS / SOLING |  |
| DRAIN                 |  |
| TAP                   |  |
| HAND PUMP             |  |
| AIR CONDITIONER       |  |
| TUBE LIGHT            |  |
| FAN                   |  |
| ROOF LIGHT            |  |
| BULB                  |  |

| AREA                      |                |
|---------------------------|----------------|
| AREA WITHIN BOUNDARY WALL | 353881.381 SFT |
| AREA OF CLINICAL BLOCK    | 26815.531 SFT  |
| PLINTH AREA OF BLOCK      | 15832.795 SFT  |

| OPENING SCHEDULE OF DOORS AND WINDOWS |       |        |         |       |        |
|---------------------------------------|-------|--------|---------|-------|--------|
| DOORS                                 | WIDTH | HEIGHT | WINDOWS | WIDTH | HEIGHT |
| D1                                    | 2'-0" | 7'-0"  | W1      | 3'-0" | 5'-0"  |
| D2                                    | 2'-6" | 7'-0"  | W2      | 4'-0" | 4'-0"  |
| D3                                    | 3'-0" | 7'-0"  | W3      | 6'-0" | 6'-0"  |
| D4                                    | 3'-6" | 7'-0"  | W4      | 8'-0" | 8'-0"  |
| D5                                    | 4'-0" | 7'-0"  | W5      | 5'-0" | 5'-0"  |
| D6                                    | 4'-6" | 7'-0"  | W6      |       |        |
| D7                                    | 5'-0" | 7'-0"  | W7      |       |        |
| D8                                    | 6'-0" | 7'-0"  | V1      | 2'-0" | 2'-0"  |
| D9                                    | 7'-0" | 7'-0"  | V2      |       |        |

Project:  
**CAD MAPPING OF TEHSIL HEAD QUARTER HOSPITALS, PUNJAB**


|                                                                                         |                                                                                                    |
|-----------------------------------------------------------------------------------------|----------------------------------------------------------------------------------------------------|
| Client:<br><br>GOVERNMENT OF THE PUNJAB<br>PRIMARY & SECONDARY<br>HEALTHCARE DEPARTMENT | Consultant:<br><br>SKAFS CONSULTANT (Pvt.)<br>Limited<br>ENGINEERING AND ENVIRONMENT<br>CONSULTANT |
|-----------------------------------------------------------------------------------------|----------------------------------------------------------------------------------------------------|

Drawing Title:  
**THQ KAHUTA HOSPITAL CLINICAL BLOCK PLAN**

Drawing No.  
**SKAFS/KAHUTA /08**

# CLINICAL BLOCK OF THQ HOSPITAL KAHUTA

## GROUND FLOOR PART 1

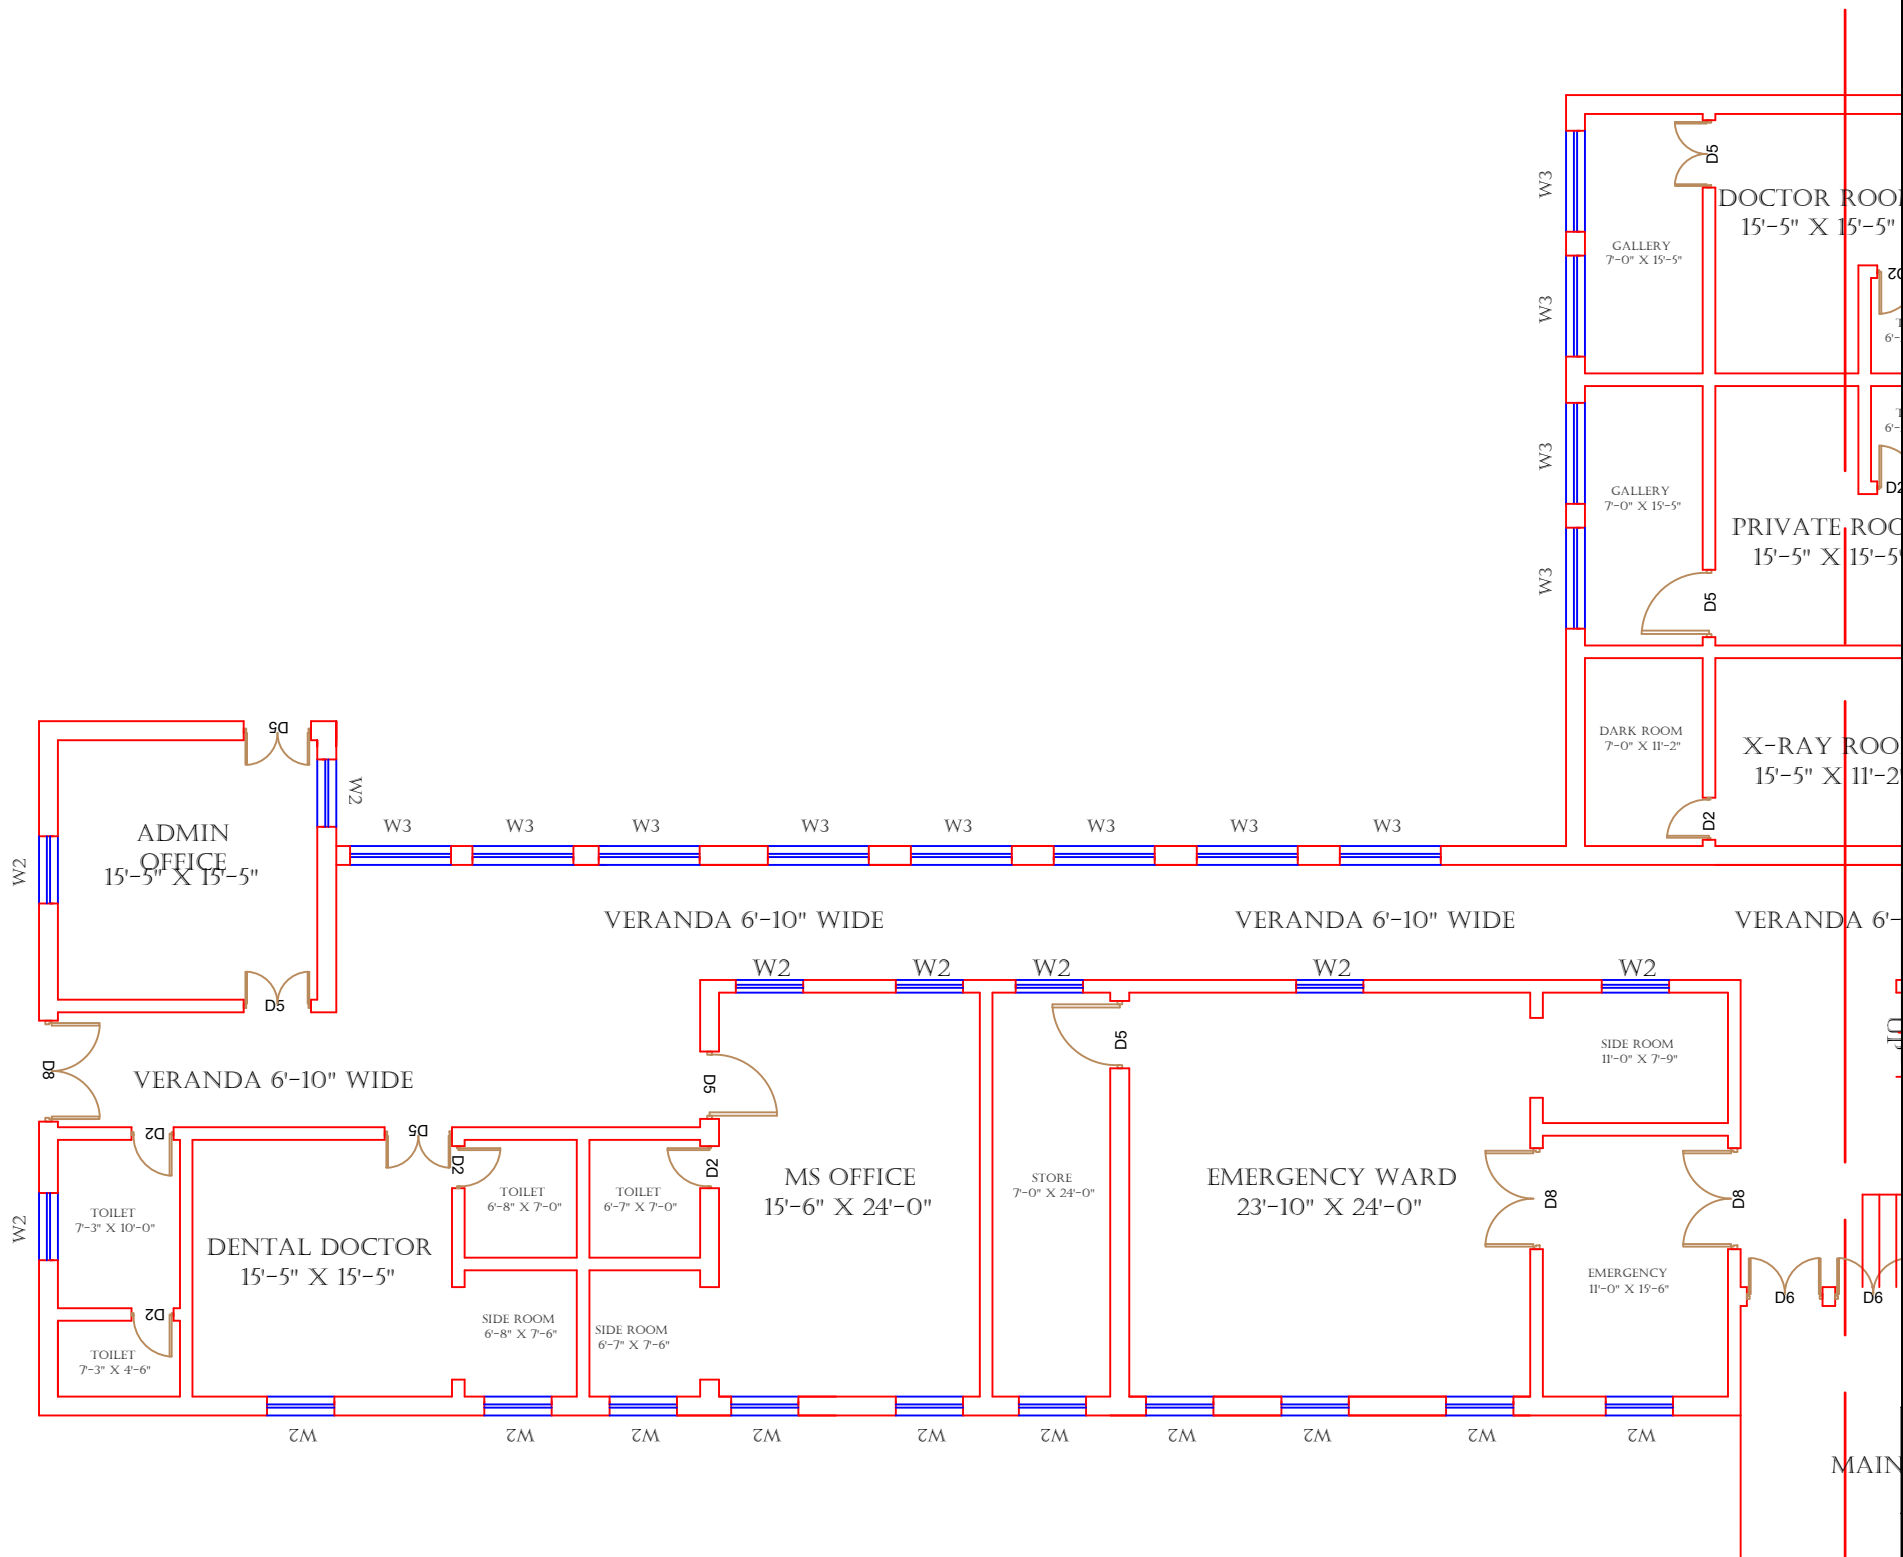

**Legends:**

|                       |  |
|-----------------------|--|
| RESIDENTIAL AREA      |  |
| ROAD                  |  |
| WALL                  |  |
| POWER LINE            |  |
| OHT                   |  |
| TREE                  |  |
| MAN HOLE              |  |
| TUBE WELL             |  |
| LIGHT POLE            |  |
| LAWNS                 |  |
| EARTHEN AREAS         |  |
| ASPHALTS ROADS        |  |
| TOUGH PAVERS          |  |
| P.C.C / PLINTH        |  |
| BOUNDARY WALL         |  |
| BRICK PAVERS / SOLING |  |
| DRAIN                 |  |
| TAP                   |  |
| HAND PUMP             |  |
| AIR CONDITIONER       |  |
| TUBE LIGHT            |  |
| FAN                   |  |
| ROOF LIGHT            |  |
| BULB                  |  |

| AREA                      |                |
|---------------------------|----------------|
| AREA WITHIN BOUNDARY WALL | 353881.381 SFT |
| AREA OF CLINICAL BLOCK    | 26815.531 SFT  |
| PLINTH AREA OF BLOCK      | 15832.795 SFT  |

| OPENING SCHEDULE OF DOORS AND WINDOWS |       |        |         |       |        |
|---------------------------------------|-------|--------|---------|-------|--------|
| DOORS                                 | WIDTH | HEIGHT | WINDOWS | WIDTH | HEIGHT |
| D1                                    | 2'-0" | 7'-0"  | W1      | 3'-0" | 5'-0"  |
| D2                                    | 2'-6" | 7'-0"  | W2      | 4'-0" | 4'-0"  |
| D3                                    | 3'-0" | 7'-0"  | W3      | 6'-0" | 6'-0"  |
| D4                                    | 3'-6" | 7'-0"  | W4      | 8'-0" | 8'-0"  |
| D5                                    | 4'-0" | 7'-0"  | W5      | 5'-0" | 5'-0"  |
| D6                                    | 4'-6" | 7'-0"  | W6      |       |        |
| D7                                    | 5'-0" | 7'-0"  | W7      |       |        |
| D8                                    | 6'-0" | 7'-0"  | V1      | 2'-0" | 2'-0"  |
| D9                                    | 7'-0" | 7'-0"  | V2      |       |        |

**Project:**  
**CAD MAPPING OF TEHSIL HEAD QUARTER HOSPITALS, PUNJAB**

**Client:**  
  
GOVERNMENT OF THE PUNJAB  
PRIMARY & SECONDARY  
HEALTHCARE DEPARTMENT

**Consultant:**  
  
SKAFS CONSULTANT (Pvt.) Limited  
ENGINEERING AND ENVIRONMENT  
CONSULTANT

**Drawing Title:**  
**THQ KAHUTA  
CLINICAL BLOCK PLAN (PART 1)**

**Drawing No.**  
**SKAFS/KAHUTA /09**

|                       |                                                                                       |
|-----------------------|---------------------------------------------------------------------------------------|
| RESIDENTIAL AREA ROAD |    |
| WALL                  |    |
| POWER LINE            |    |
| OHT                   |    |
| TREE                  |    |
| MAN HOLE              |    |
| TUBE WELL             |    |
| LIGHT POLE            |    |
| LAWNS                 |    |
| EARTHEN AREAS         |    |
| ASPHALTS ROADS        |    |
| TOUGH PAVERS          |    |
| P.C.C / PLINTH        |    |
| BOUNDARY WALL         |    |
| BRICK PAVERS / SOLING |    |
| DRAIN                 |    |
| TAP                   |  |
| HAND PUMP             |  |
| AIR CONDITIONER       |  |
| TUBE LIGHT            |  |
| FAN                   |  |
| ROOF LIGHT            |  |
| BULB                  |  |

| AREA                      |                |
|---------------------------|----------------|
| AREA WITHIN BOUNDARY WALL | 353881.381 SFT |
| AREA OF CLINICAL BLOCK    | 26815.531 SFT  |
| PLINTH AREA OF BLOCK      | 15832.795 SFT  |

| OPENING SCHEDULE OF DOORS AND WINDOWS |       |        |         |       |        |
|---------------------------------------|-------|--------|---------|-------|--------|
| DOORS                                 | WIDTH | HEIGHT | WINDOWS | WIDTH | HEIGHT |
| D1                                    | 2'-0" | 7'-0"  | W1      | 3'-0" | 5'-0"  |
| D2                                    | 2'-6" | 7'-0"  | W2      | 4'-0" | 4'-0"  |
| D3                                    | 3'-0" | 7'-0"  | W3      | 6'-0" | 6'-0"  |
| D4                                    | 3'-6" | 7'-0"  | W4      | 8'-0" | 8'-0"  |
| D5                                    | 4'-0" | 7'-0"  | W5      | 5'-0" | 5'-0"  |
| D6                                    | 4'-6" | 7'-0"  | W6      |       |        |
| D7                                    | 5'-0" | 7'-0"  | W7      |       |        |
| D8                                    | 6'-0" | 7'-0"  | V1      | 2'-0" | 2'-0"  |
| D9                                    | 7'-0" | 7'-0"  | V2      |       |        |

Project: **CAD MAPPING OF TEHSIL  
HEAD QUARTER HOSPITALS,  
PUNJAB**

|                                                                                                                                                                                                          |                                                                                                                                                                                                                         |
|----------------------------------------------------------------------------------------------------------------------------------------------------------------------------------------------------------|-------------------------------------------------------------------------------------------------------------------------------------------------------------------------------------------------------------------------|
| <p><b>Client:</b></p>  <p><b>GOVERNMENT OF THE PUNJAB<br/>PRIMARY &amp; SECONDARY<br/>HEALTHCARE DEPARTMENT</b></p> | <p><b>Consultant:</b></p>  <p><b>SKAFS CONSULTANT (Pvt.)<br/>Limited</b><br/><i>ENGINEERING AND ENVIRONMENT<br/>CONSULTANT</i></p> |
|----------------------------------------------------------------------------------------------------------------------------------------------------------------------------------------------------------|-------------------------------------------------------------------------------------------------------------------------------------------------------------------------------------------------------------------------|


Drawing Title: **THQ KAHUTA  
CLINICAL BLOCK PLAN (PART 2)**

Drawing No. **SKAFS/KAHUTA /10**



# CLINICAL BLOCK OF THQ HOSPITAL KAHUTA

## GROUND FLOOR PART 3

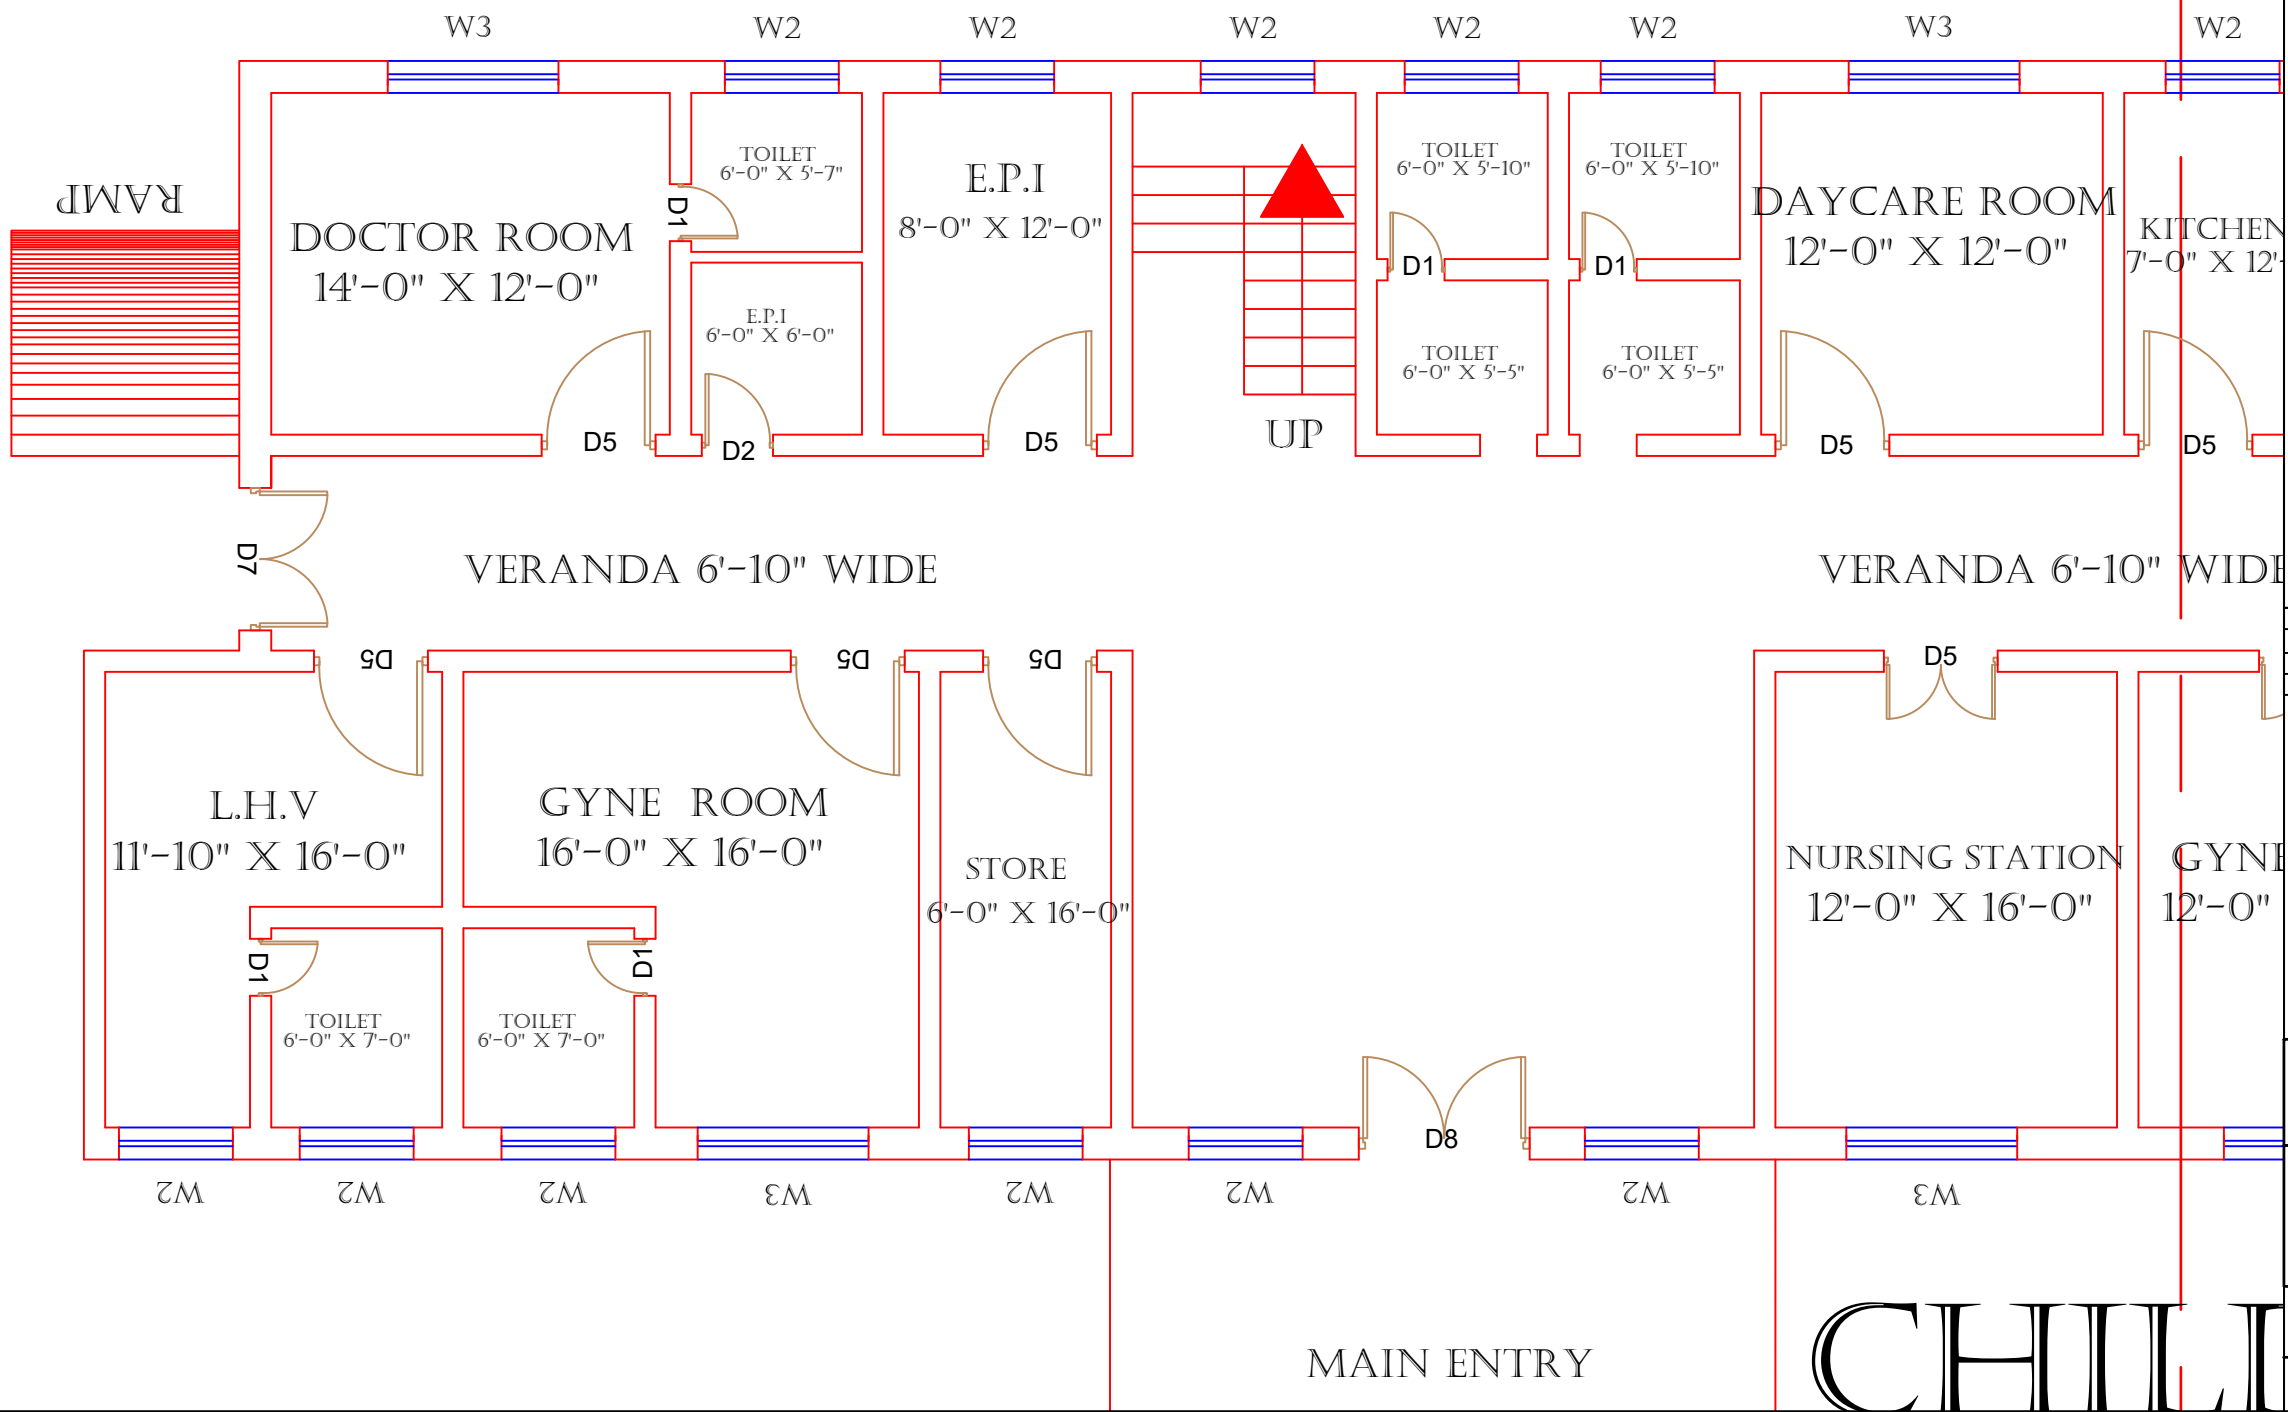

| Legends:              |  |
|-----------------------|--|
| RESIDENTIAL AREA      |  |
| ROAD                  |  |
| WALL                  |  |
| POWER LINE            |  |
| OHT                   |  |
| TREE                  |  |
| MAN HOLE              |  |
| TUBE WELL             |  |
| LIGHT POLE            |  |
| LAWNS                 |  |
| EARTHEN AREAS         |  |
| ASPHALTS ROADS        |  |
| TOUGH PAVERS          |  |
| P.C.C / PLINTH        |  |
| BOUNDARY WALL         |  |
| BRICK PAVERS / SOLING |  |
| DRAIN                 |  |
| TAP                   |  |
| HAND PUMP             |  |
| AIR CONDITIONER       |  |
| TUBE LIGHT            |  |
| FAN                   |  |
| ROOF LIGHT            |  |
| BULB                  |  |

| AREA                      |                |
|---------------------------|----------------|
| AREA WITHIN BOUNDARY WALL | 353881.381 SFT |
| AREA OF CLINICAL BLOCK    | 26815.531 SFT  |
| PLINTH AREA OF BLOCK      | 15832.795 SFT  |

| OPENING SCHEDULE OF DOORS AND WINDOWS |       |        |         |       |        |
|---------------------------------------|-------|--------|---------|-------|--------|
| DOORS                                 | WIDTH | HEIGHT | WINDOWS | WIDTH | HEIGHT |
| D1                                    | 2'-0" | 7'-0"  | W1      | 3'-0" | 5'-0"  |
| D2                                    | 2'-6" | 7'-0"  | W2      | 4'-0" | 4'-0"  |
| D3                                    | 3'-0" | 7'-0"  | W3      | 6'-0" | 6'-0"  |
| D4                                    | 3'-6" | 7'-0"  | W4      | 8'-0" | 8'-0"  |
| D5                                    | 4'-0" | 7'-0"  | W5      | 5'-0" | 5'-0"  |
| D6                                    | 4'-6" | 7'-0"  | W6      |       |        |
| D7                                    | 5'-0" | 7'-0"  | W7      |       |        |
| D8                                    | 6'-0" | 7'-0"  | V1      | 2'-0" | 2'-0"  |
| D9                                    | 7'-0" | 7'-0"  | V2      |       |        |

Project:  
**CAD MAPPING OF TEHSIL HEAD QUARTER HOSPITALS, PUNJAB**


|                                                                                         |                                                                                                    |
|-----------------------------------------------------------------------------------------|----------------------------------------------------------------------------------------------------|
| Client:<br><br>GOVERNMENT OF THE PUNJAB<br>PRIMARY & SECONDARY<br>HEALTHCARE DEPARTMENT | Consultant:<br><br>SKAFS CONSULTANT (Pvt.)<br>Limited<br>ENGINEERING AND ENVIRONMENT<br>CONSULTANT |
|-----------------------------------------------------------------------------------------|----------------------------------------------------------------------------------------------------|

Drawing Title: **THQ KAHUTA CLINICAL BLOCK PLAN (PART 3)**

Drawing No. **SKAFS/KAHUTA /11**

# CLINICAL BLOCK OF THQ HOSPITAL KAHUTA

## GROUND FLOOR PART 4

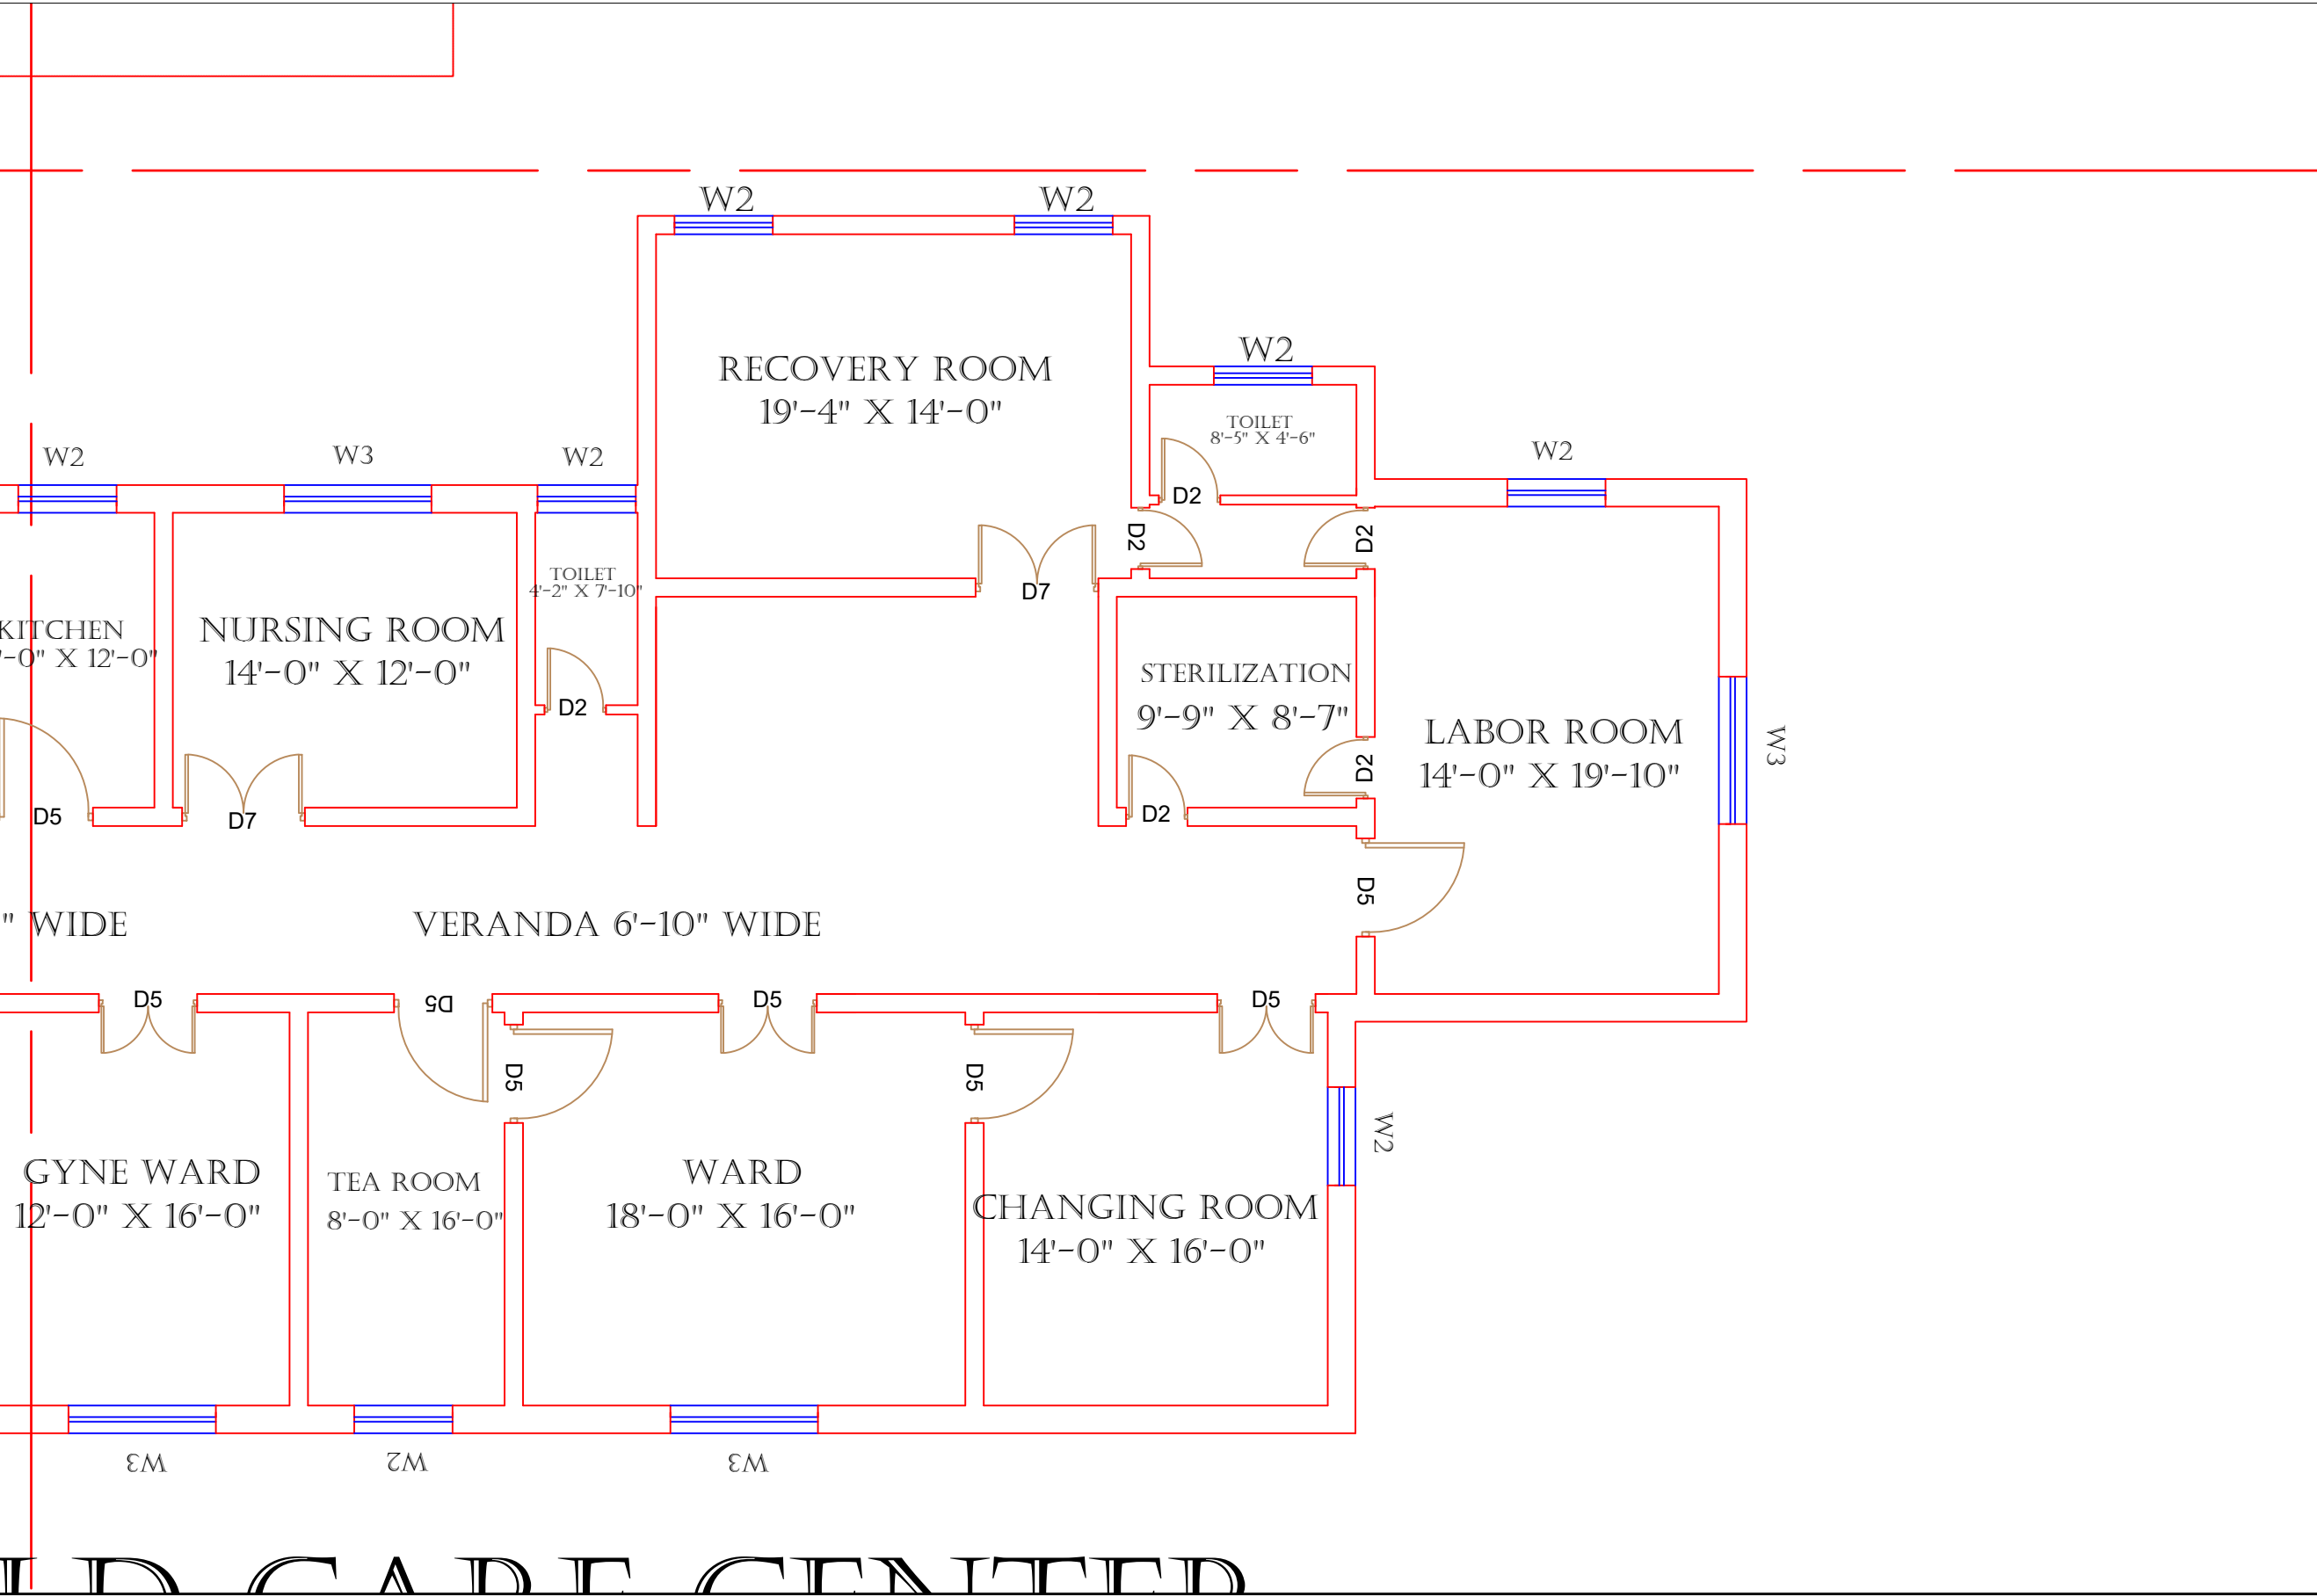

**Legends:**

|                       |  |
|-----------------------|--|
| RESIDENTIAL AREA      |  |
| ROAD                  |  |
| WALL                  |  |
| POWER LINE            |  |
| OHT                   |  |
| TREE                  |  |
| MAN HOLE              |  |
| TUBE WELL             |  |
| LIGHT POLE            |  |
| LAWNS                 |  |
| EARTHEN AREAS         |  |
| ASPHALTS ROADS        |  |
| TOUGH PAVERS          |  |
| P.C.C / PLINTH        |  |
| BOUNDARY WALL         |  |
| BRICK PAVERS / SOLING |  |
| DRAIN                 |  |
| TAP                   |  |
| HAND PUMP             |  |
| AIR CONDITIONER       |  |
| TUBE LIGHT            |  |
| FAN                   |  |
| ROOF LIGHT            |  |
| BULB                  |  |

| AREA                      |                |
|---------------------------|----------------|
| AREA WITHIN BOUNDARY WALL | 353881.381 SFT |
| AREA OF CLINICAL BLOCK    | 26815.531 SFT  |
| PLINTH AREA OF BLOCK      | 15832.795 SFT  |

| OPENING SCHEDULE OF DOORS AND WINDOWS |       |        |         |       |        |
|---------------------------------------|-------|--------|---------|-------|--------|
| DOORS                                 | WIDTH | HEIGHT | WINDOWS | WIDTH | HEIGHT |
| D1                                    | 2'-0" | 7'-0"  | W1      | 3'-0" | 5'-0"  |
| D2                                    | 2'-6" | 7'-0"  | W2      | 4'-0" | 4'-0"  |
| D3                                    | 3'-0" | 7'-0"  | W3      | 6'-0" | 6'-0"  |
| D4                                    | 3'-6" | 7'-0"  | W4      | 8'-0" | 8'-0"  |
| D5                                    | 4'-0" | 7'-0"  | W5      | 5'-0" | 5'-0"  |
| D6                                    | 4'-6" | 7'-0"  | W6      |       |        |
| D7                                    | 5'-0" | 7'-0"  | W7      |       |        |
| D8                                    | 6'-0" | 7'-0"  | V1      | 2'-0" | 2'-0"  |
| D9                                    | 7'-0" | 7'-0"  | V2      |       |        |

Project: **CAD MAPPING OF TEHSIL HEAD QUARTER HOSPITALS, PUNJAB**


|                                                                          |                                                                                 |
|--------------------------------------------------------------------------|---------------------------------------------------------------------------------|
| Client:                                                                  | Consultant:                                                                     |
| GOVERNMENT OF THE PUNJAB<br>PRIMARY & SECONDARY<br>HEALTHCARE DEPARTMENT | SKAFS CONSULTANT (Pvt.)<br>Limited<br>ENGINEERING AND ENVIRONMENT<br>CONSULTANT |

Drawing Title: **THQ KAHUTA CLINICAL BLOCK PLAN (PART 4)**

Drawing No. **SKAFS/KAHUTA /12**

# CLINICAL BLOCK OF THQ HOSPITAL KAHUTA

## FIRST FLOOR

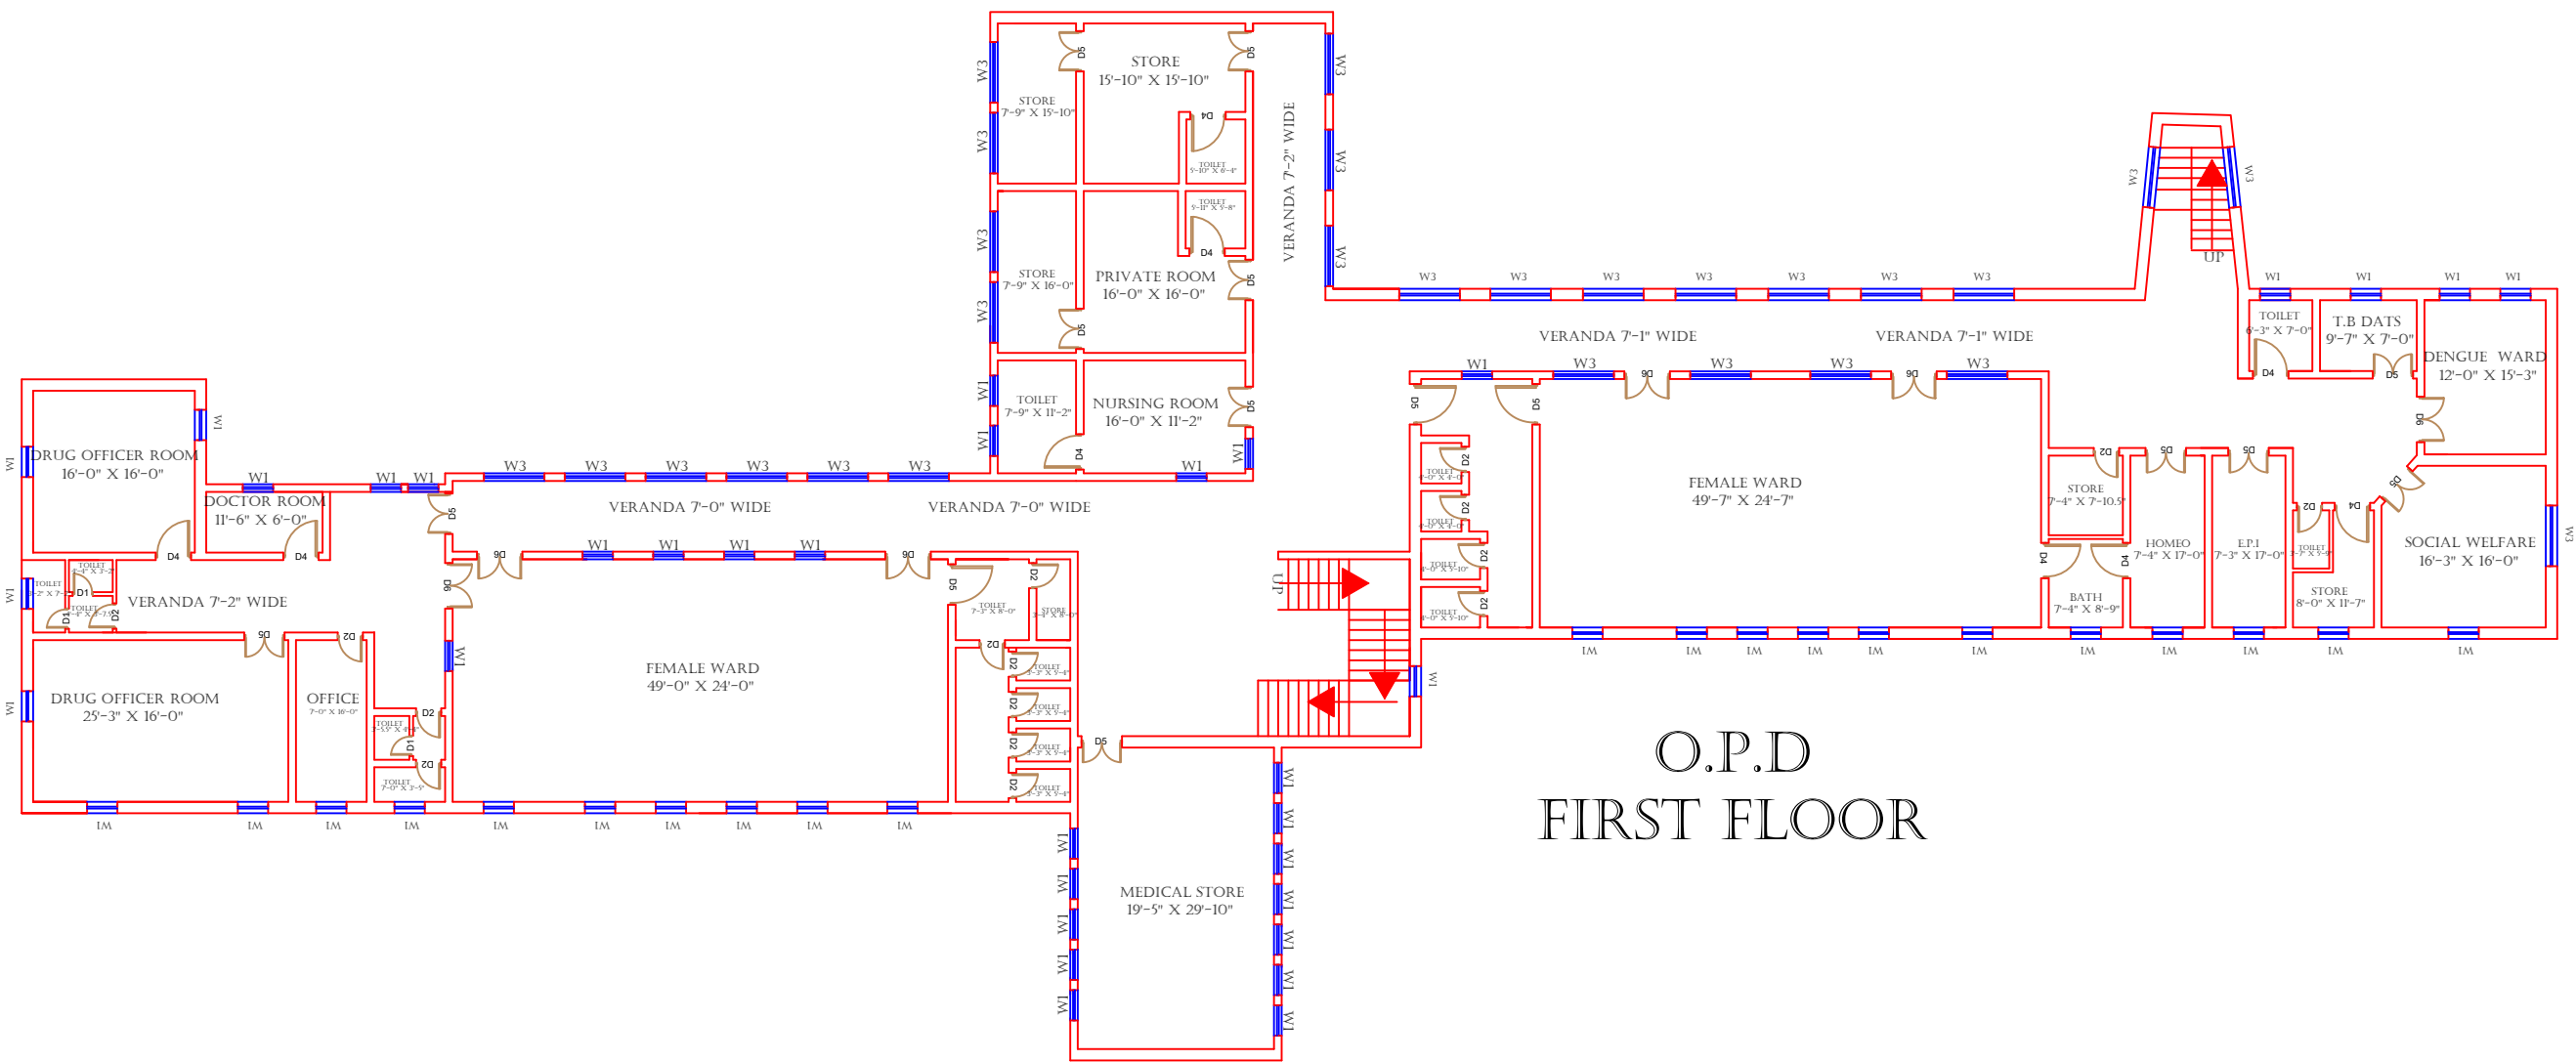

**Legends:**

|                       |  |
|-----------------------|--|
| RESIDENTIAL AREA      |  |
| ROAD                  |  |
| WALL                  |  |
| POWER LINE            |  |
| OHT                   |  |
| TREE                  |  |
| MAN HOLE              |  |
| TUBE WELL             |  |
| LIGHT POLE            |  |
| LAWNS                 |  |
| EARTHEN AREAS         |  |
| ASPHALTS ROADS        |  |
| TOUGH PAVERS          |  |
| P.C.C / PLINTH        |  |
| BOUNDARY WALL         |  |
| BRICK PAVERS / SOLING |  |
| DRAIN                 |  |
| TAP                   |  |
| HAND PUMP             |  |
| AIR CONDITIONER       |  |
| TUBE LIGHT            |  |
| FAN                   |  |
| ROOF LIGHT            |  |
| BULB                  |  |

| AREA                      |                |
|---------------------------|----------------|
| AREA WITHIN BOUNDARY WALL | 353881.381 SFT |
| AREA OF CLINICAL BLOCK    | 26815.531 SFT  |
| PLINTH AREA OF BLOCK      | 15832.795 SFT  |

| OPENING SCHEDULE OF DOORS AND WINDOWS |       |        |         |       |        |
|---------------------------------------|-------|--------|---------|-------|--------|
| DOORS                                 | WIDTH | HEIGHT | WINDOWS | WIDTH | HEIGHT |
| D1                                    | 2'-0" | 7'-0"  | W1      | 3'-0" | 5'-0"  |
| D2                                    | 2'-6" | 7'-0"  | W2      | 4'-0" | 4'-0"  |
| D3                                    | 3'-0" | 7'-0"  | W3      | 6'-0" | 6'-0"  |
| D4                                    | 3'-6" | 7'-0"  | W4      | 8'-0" | 8'-0"  |
| D5                                    | 4'-0" | 7'-0"  | W5      | 5'-0" | 5'-0"  |
| D6                                    | 4'-6" | 7'-0"  | W6      |       |        |
| D7                                    | 5'-0" | 7'-0"  | W7      |       |        |
| D8                                    | 6'-0" | 7'-0"  | V1      | 2'-0" | 2'-0"  |
| D9                                    | 7'-0" | 7'-0"  | V2      |       |        |

Project:  
**CAD MAPPING OF TEHSIL HEAD QUARTER HOSPITALS, PUNJAB**



|                                                                                         |                                                                                              |
|-----------------------------------------------------------------------------------------|----------------------------------------------------------------------------------------------|
| Client:<br><br>GOVERNMENT OF THE PUNJAB<br>PRIMARY & SECONDARY<br>HEALTHCARE DEPARTMENT | Consultant:<br><br>SKAFS CONSULTANT (Pvt.) Limited<br>ENGINEERING AND ENVIRONMENT CONSULTANT |
|-----------------------------------------------------------------------------------------|----------------------------------------------------------------------------------------------|

Drawing Title:  
**THQ KAHUTA FIRST FLOOR PLAN**

Drawing No.  
**SKAFS/KAHUTA /13**

# ELECTRICAL LAYOUT PLAN OF THQ HOSPITAL KAHUTA

## GROUND FLOOR

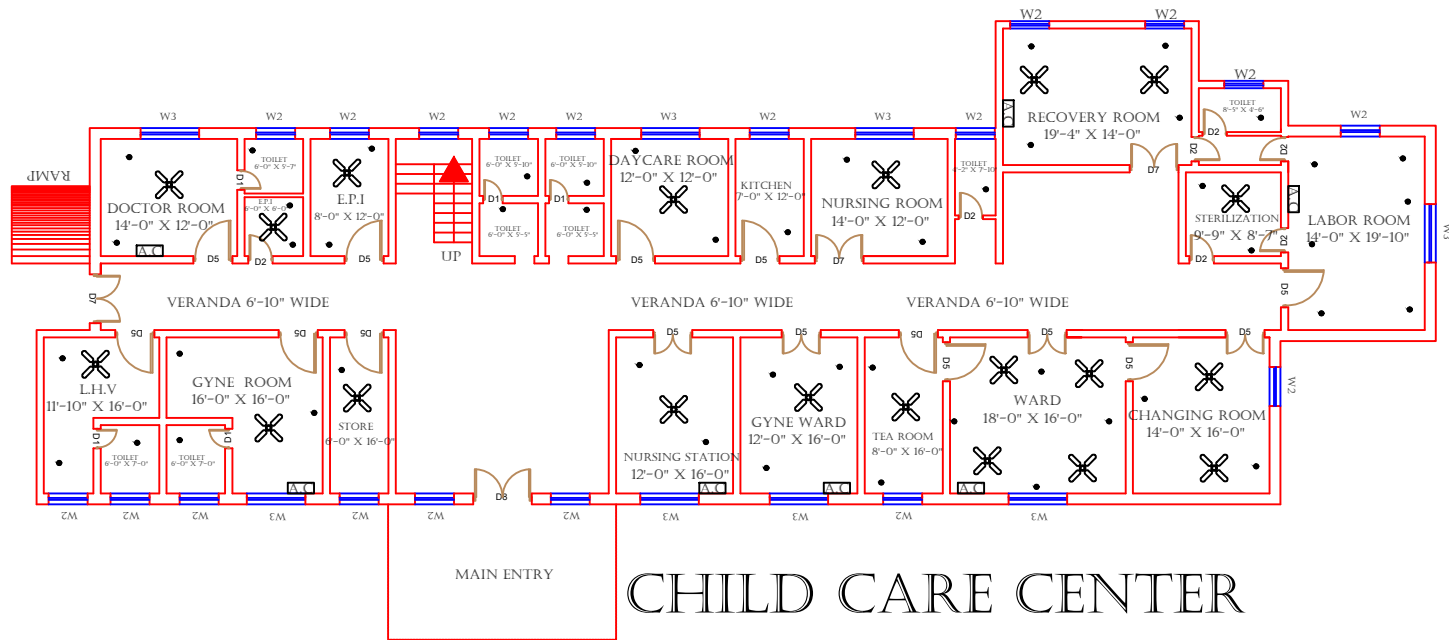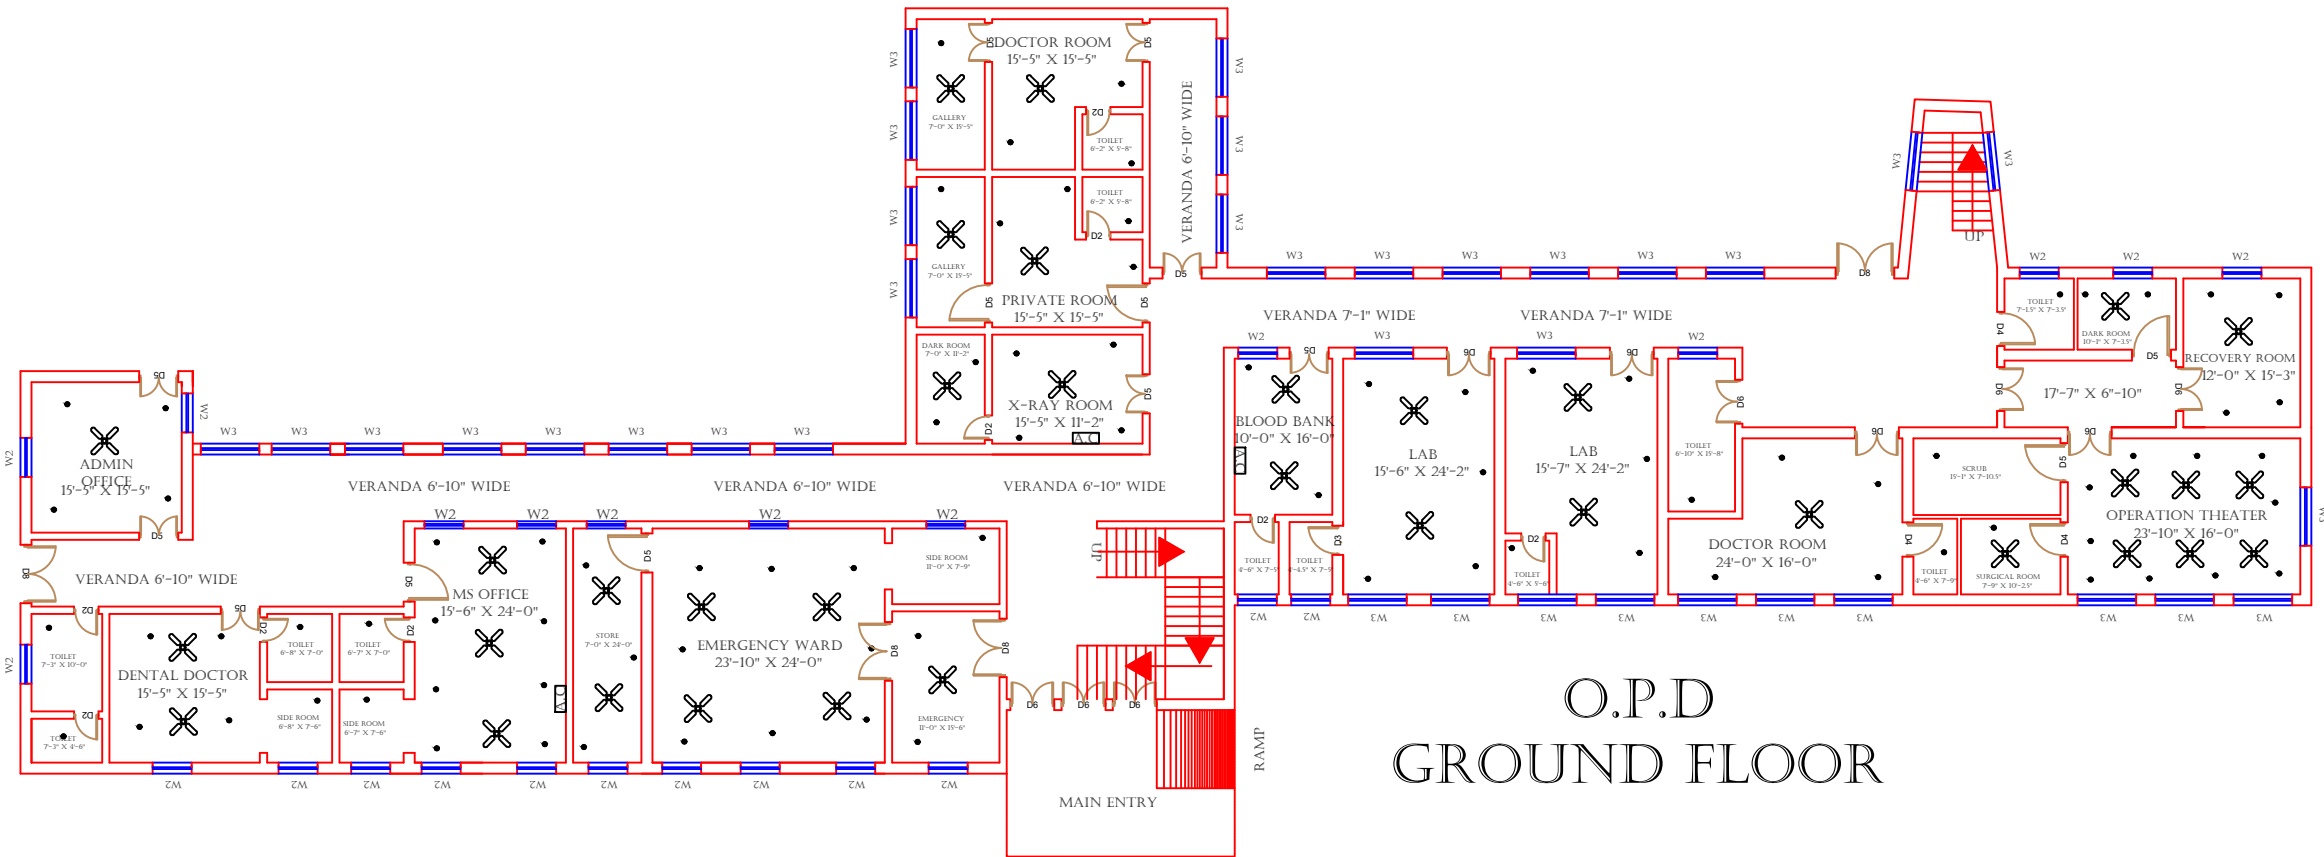

### Legends:

|                       |  |
|-----------------------|--|
| RESIDENTIAL AREA      |  |
| ROAD                  |  |
| WALL                  |  |
| POWER LINE            |  |
| OHT                   |  |
| TREE                  |  |
| MAN HOLE              |  |
| TUBE WELL             |  |
| LIGHT POLE            |  |
| LAWNS                 |  |
| EARTHEN AREAS         |  |
| ASPHALTS ROADS        |  |
| TOUGH PAVERS          |  |
| P.C.C / PLINTH        |  |
| BOUNDARY WALL         |  |
| BRICK PAVERS / SOLING |  |
| DRAIN                 |  |
| TAP                   |  |
| HAND PUMP             |  |
| AIR CONDITIONER       |  |
| TUBE LIGHT            |  |
| FAN                   |  |
| ROOF LIGHT            |  |
| BULB                  |  |

| AREA                      |                |
|---------------------------|----------------|
| AREA WITHIN BOUNDARY WALL | 353881.381 SFT |
| AREA OF CLINICAL BLOCK    | 26815.531 SFT  |
| PLINTH AREA OF BLOCK      | 15832.795 SFT  |

| OPENING SCHEDULE OF DOORS AND WINDOWS |       |        |         |       |        |
|---------------------------------------|-------|--------|---------|-------|--------|
| DOORS                                 | WIDTH | HEIGHT | WINDOWS | WIDTH | HEIGHT |
| D1                                    | 2'-0" | 7'-0"  | W1      | 3'-0" | 5'-0"  |
| D2                                    | 2'-6" | 7'-0"  | W2      | 4'-0" | 4'-0"  |
| D3                                    | 3'-0" | 7'-0"  | W3      | 6'-0" | 6'-0"  |
| D4                                    | 3'-6" | 7'-0"  | W4      | 8'-0" | 8'-0"  |
| D5                                    | 4'-0" | 7'-0"  | W5      | 5'-0" | 5'-0"  |
| D6                                    | 4'-6" | 7'-0"  | W6      |       |        |
| D7                                    | 5'-0" | 7'-0"  | W7      |       |        |
| D8                                    | 6'-0" | 7'-0"  | V1      | 2'-0" | 2'-0"  |
| D9                                    | 7'-0" | 7'-0"  | V2      |       |        |

Project: **CAD MAPPING OF TEHSIL HEAD QUARTER HOSPITALS, PUNJAB**

|                                                                              |                                                                                     |
|------------------------------------------------------------------------------|-------------------------------------------------------------------------------------|
| Client:                                                                      | Consultant:                                                                         |
| <br>GOVERNMENT OF THE PUNJAB<br>PRIMARY & SECONDARY<br>HEALTHCARE DEPARTMENT | <br>SKAFS CONSULTANT (Pvt.)<br>Limited<br>ENGINEERING AND ENVIRONMENT<br>CONSULTANT |


Drawing Title: **THQ KAHUTA ELECTRICAL PLAN (GROUND FLOOR)**

Drawing No. **SKAFS/KAHUTA /14**



# ELECTRICAL LAYOUT PLAN OF THQ HOSPITAL KAHUTA

## FIRST FLOOR

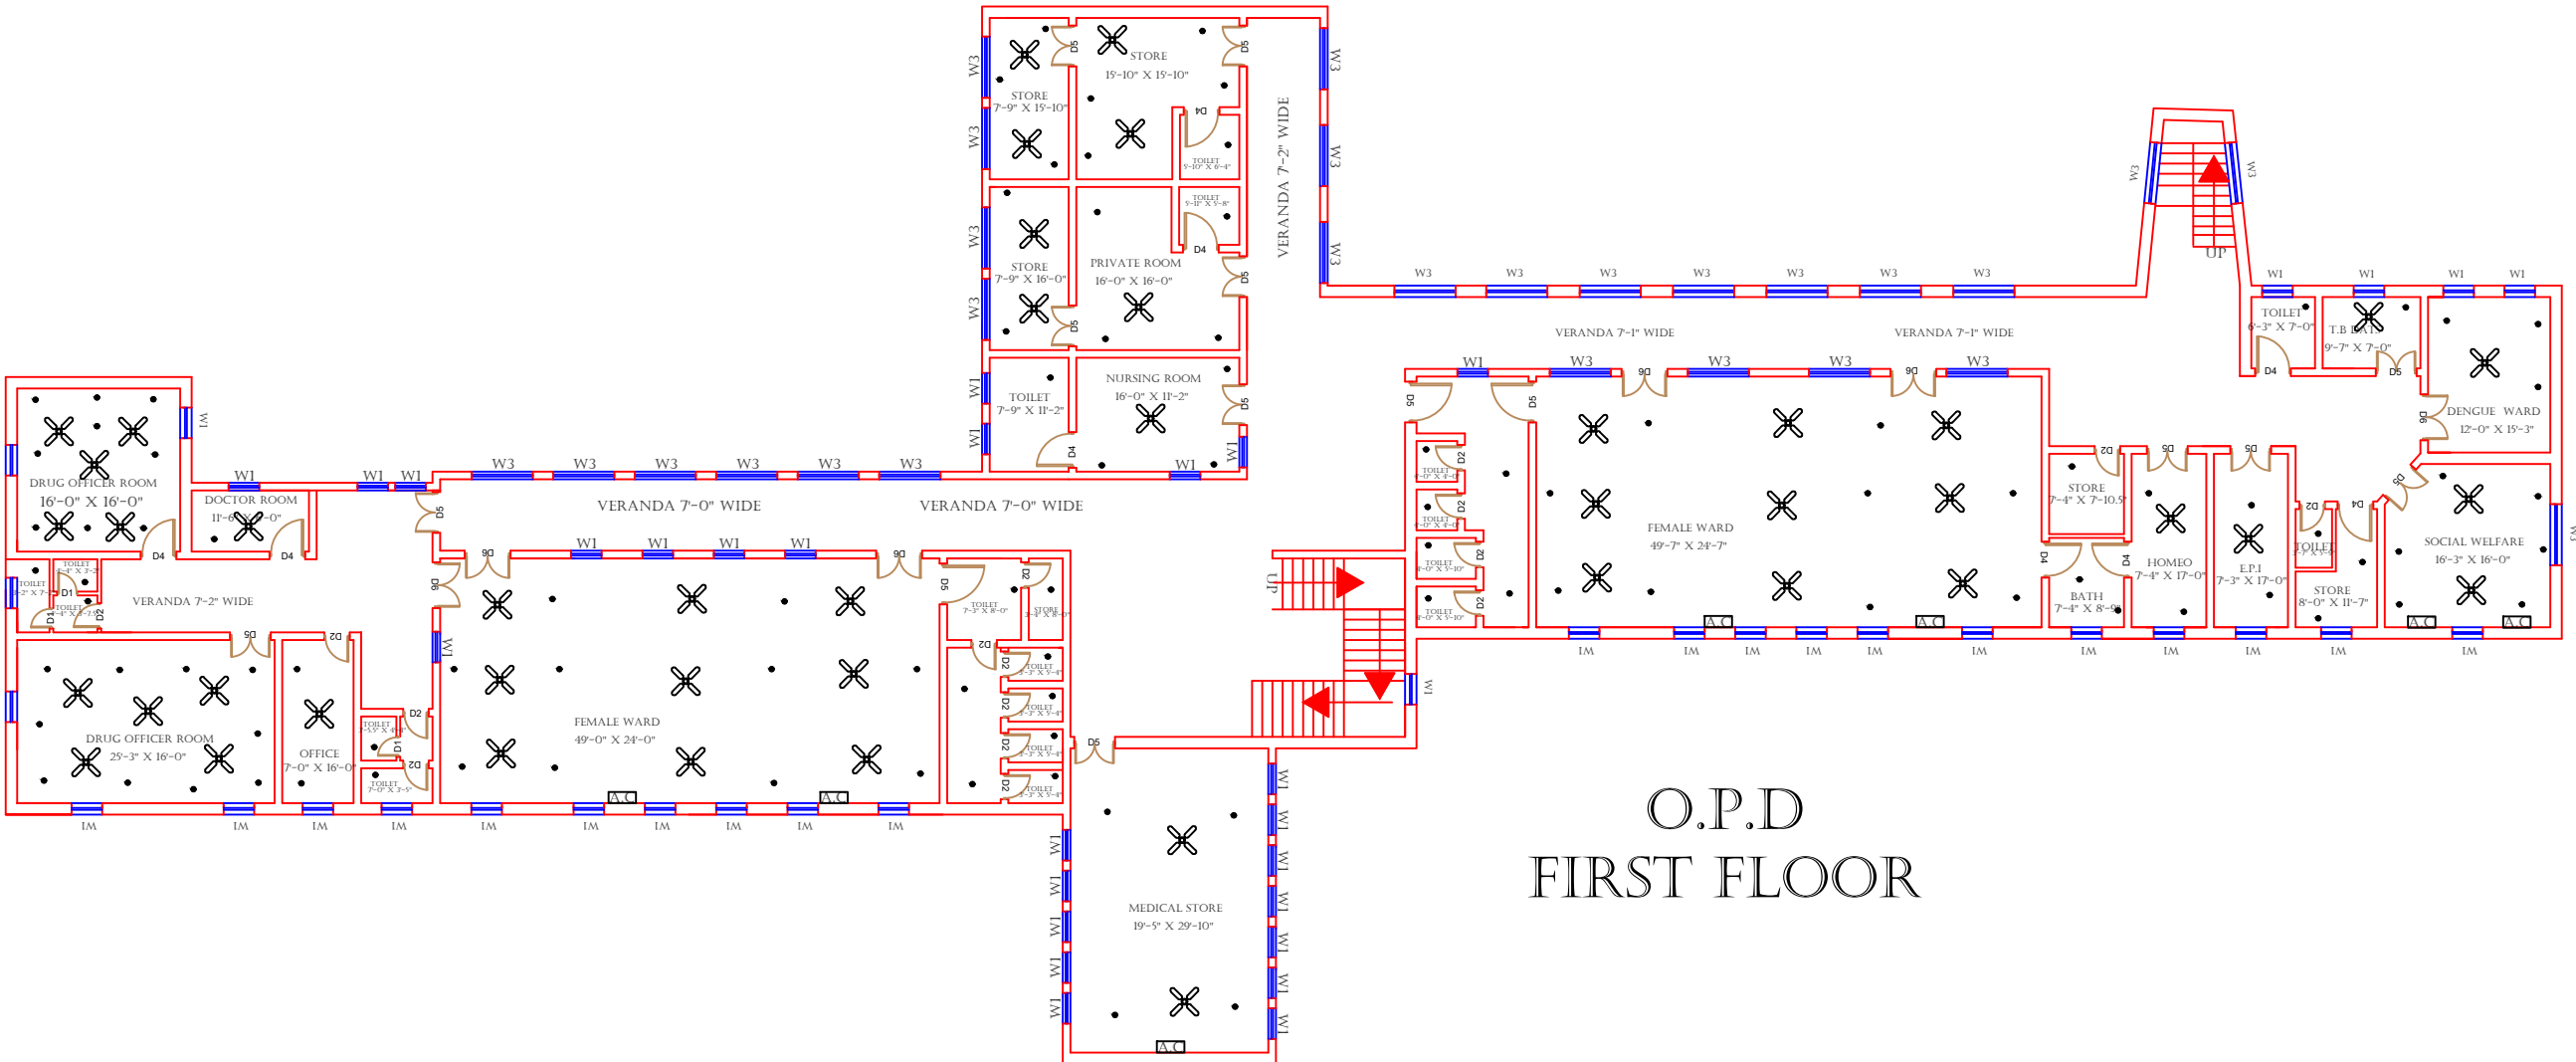

O.P.D  
FIRST FLOOR

**Legends:**

|                       |  |
|-----------------------|--|
| RESIDENTIAL AREA      |  |
| ROAD                  |  |
| WALL                  |  |
| POWER LINE            |  |
| OHT                   |  |
| TREE                  |  |
| MAN HOLE              |  |
| TUBE WELL             |  |
| LIGHT POLE            |  |
| LAWNS                 |  |
| EARTHEN AREAS         |  |
| ASPHALTS ROADS        |  |
| TOUGH PAVERS          |  |
| P.C.C / PLINTH        |  |
| BOUNDARY WALL         |  |
| BRICK PAVERS / SOLING |  |
| DRAIN                 |  |
| TAP                   |  |
| HAND PUMP             |  |
| AIR CONDITIONER       |  |
| TUBE LIGHT            |  |
| FAN                   |  |
| ROOF LIGHT            |  |
| BULB                  |  |

| AREA                      |                |
|---------------------------|----------------|
| AREA WITHIN BOUNDARY WALL | 353881.381 SFT |
| AREA OF CLINICAL BLOCK    | 26815.531 SFT  |
| PLINTH AREA OF BLOCK      | 15832.795 SFT  |

| OPENING SCHEDULE OF DOORS AND WINDOWS |       |        |         |       |        |
|---------------------------------------|-------|--------|---------|-------|--------|
| DOORS                                 | WIDTH | HEIGHT | WINDOWS | WIDTH | HEIGHT |
| D1                                    | 2'-0" | 7'-0"  | W1      | 3'-0" | 5'-0"  |
| D2                                    | 2'-6" | 7'-0"  | W2      | 4'-0" | 4'-0"  |
| D3                                    | 3'-0" | 7'-0"  | W3      | 6'-0" | 6'-0"  |
| D4                                    | 3'-6" | 7'-0"  | W4      | 8'-0" | 8'-0"  |
| D5                                    | 4'-0" | 7'-0"  | W5      | 5'-0" | 5'-0"  |
| D6                                    | 4'-6" | 7'-0"  | W6      |       |        |
| D7                                    | 5'-0" | 7'-0"  | W7      |       |        |
| D8                                    | 6'-0" | 7'-0"  | V1      | 2'-0" | 2'-0"  |
| D9                                    | 7'-0" | 7'-0"  | V2      |       |        |

Project: CAD MAPPING OF TEHSIL HEAD QUARTER HOSPITALS, PUNJAB

|                                                                                         |                                                                                                 |
|-----------------------------------------------------------------------------------------|-------------------------------------------------------------------------------------------------|
| Client:<br><br>GOVERNMENT OF THE PUNJAB<br>PRIMARY & SECONDARY<br>HEALTHCARE DEPARTMENT | Consultant:<br><br>SKAFS CONSULTANT (Pvt.) Limited<br>ENGINEERING AND ENVIRONMENT<br>CONSULTANT |
|-----------------------------------------------------------------------------------------|-------------------------------------------------------------------------------------------------|

Drawing Title: THQ KAHUTA ELECTRICAL PLAN (FIRST FLOOR)

Drawing No. SKAFS/KAHUTA /15