


MASTER PLAN OF THQ HOSPITAL MURREE

PART 1

PART 2

PART 3

PART 4

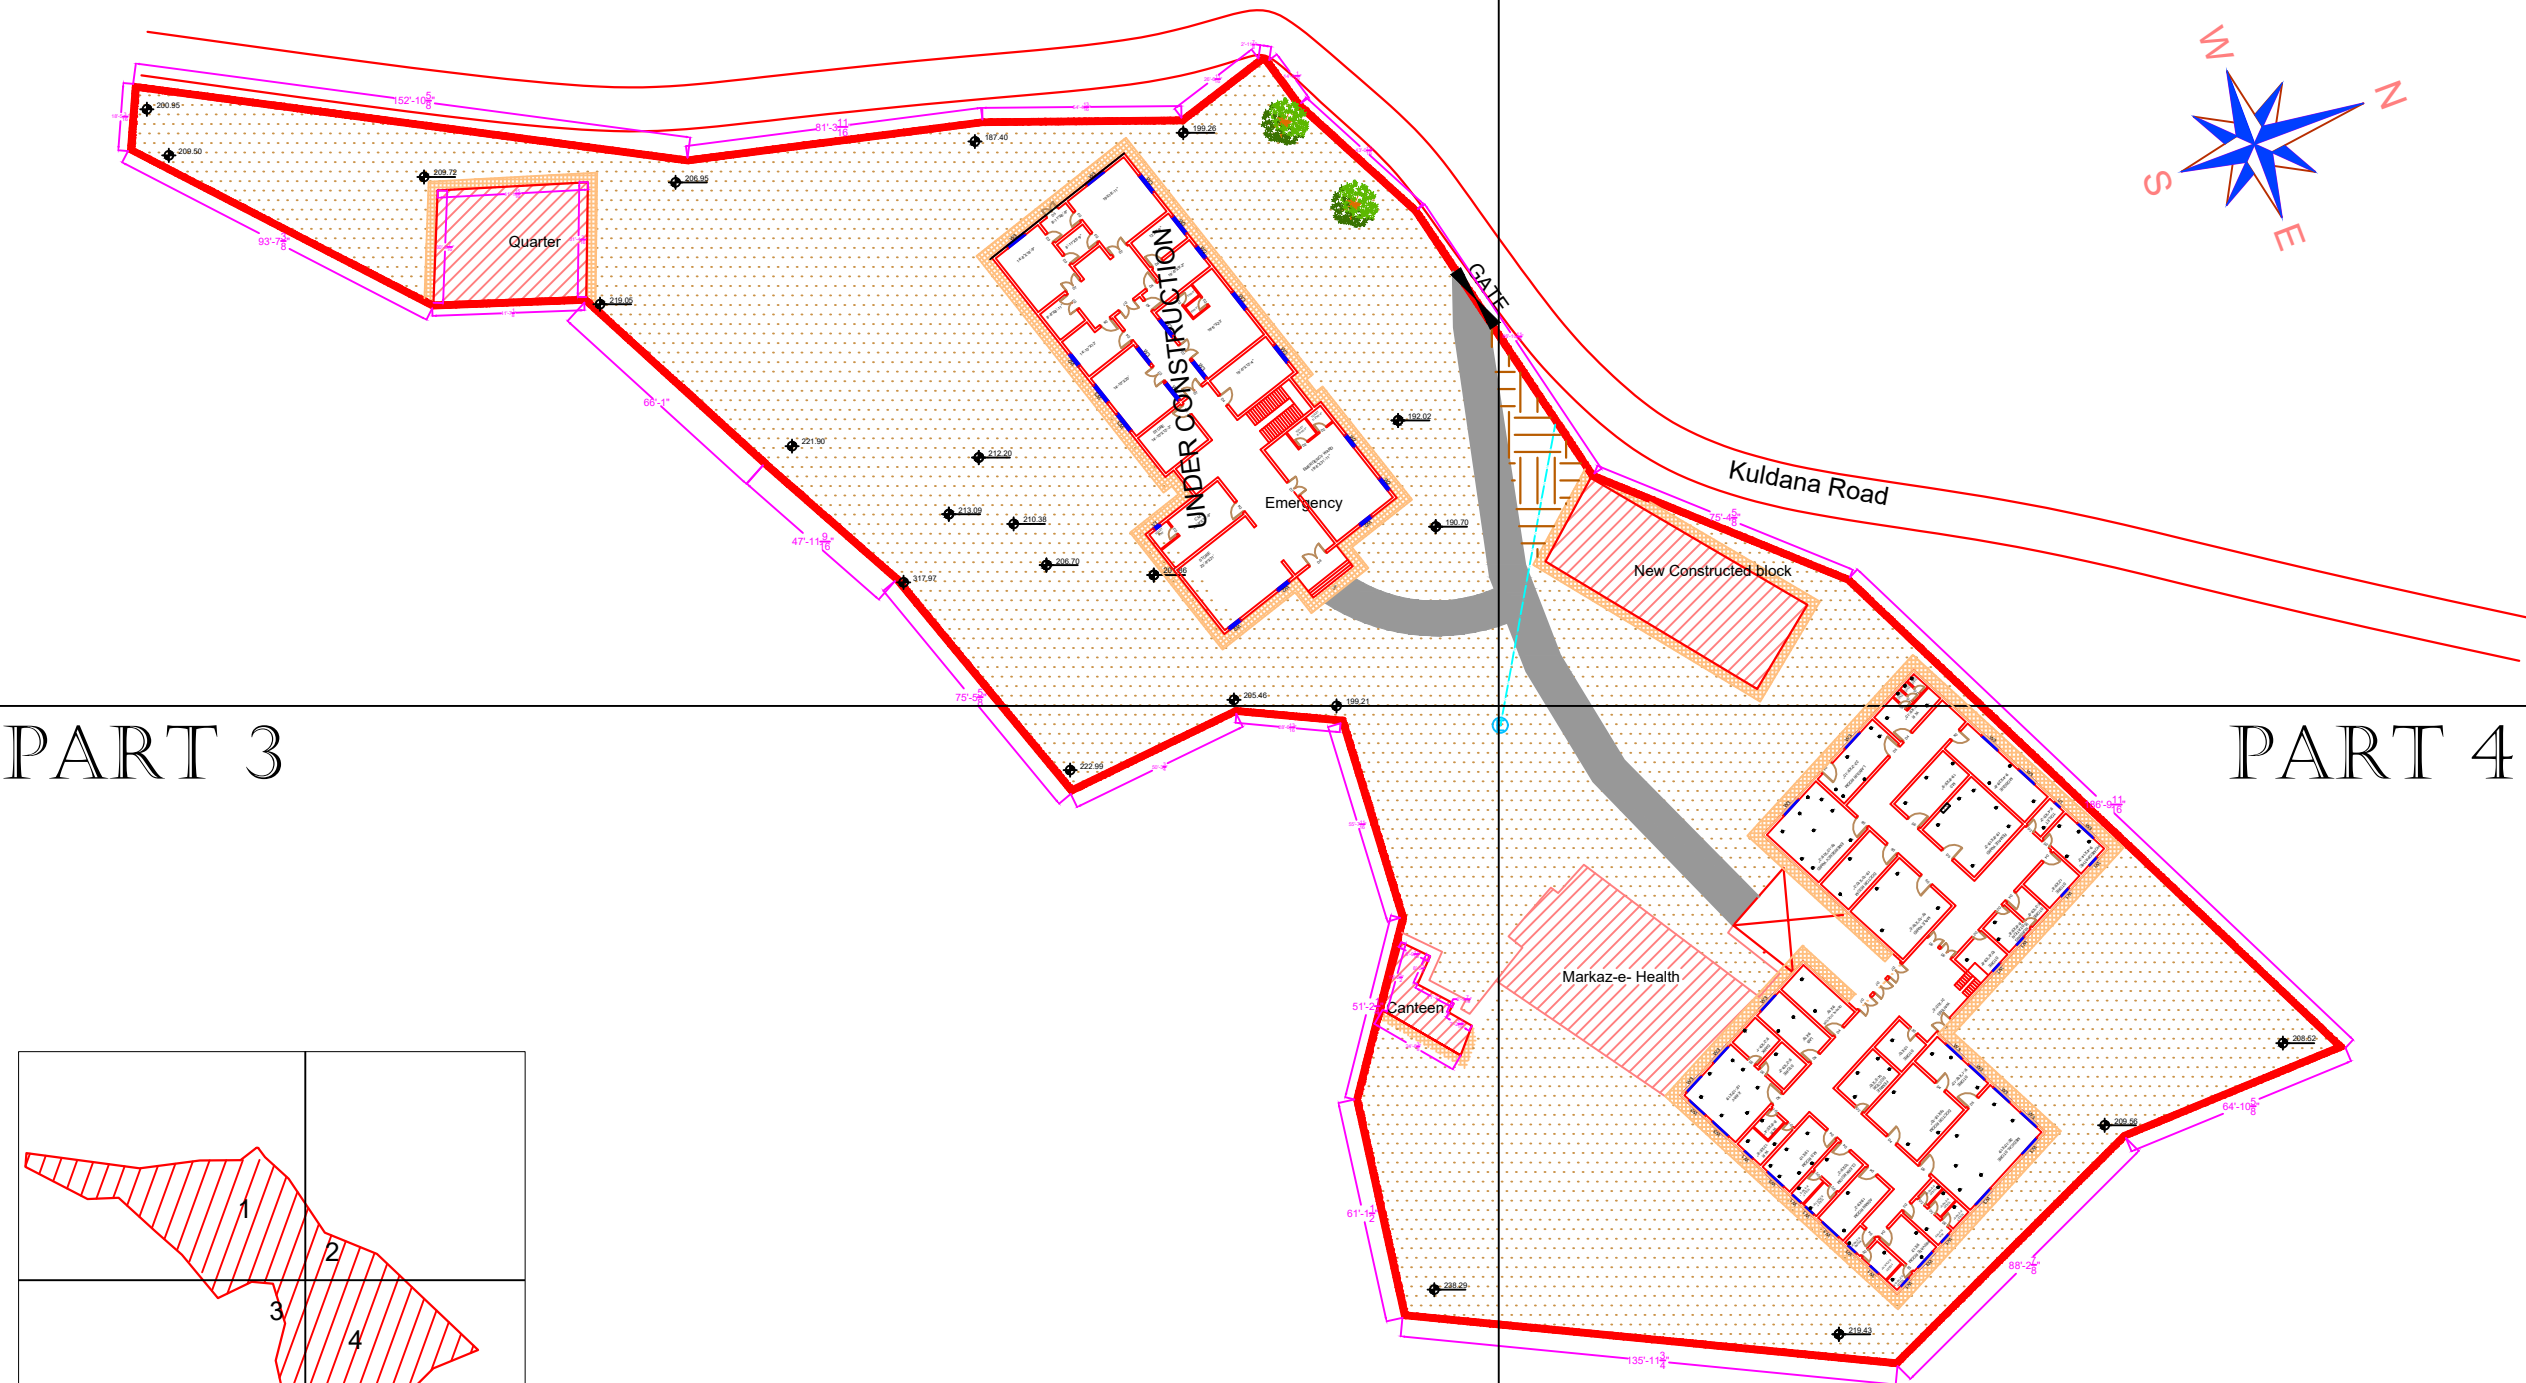

Legends:

Residential Area	
Road	
Wall	
Power Line	
OHT	
Tree	
Man Hole	
Tube Well	
Light Pole	
Lawns	
Earthen Areas	
Asphalts Roads	
Tough Pavers	
P.C.C / Plinth Protection	
Boundary Wall	
Brick Pavers / Soling	
Drain	
Tap	
Hand Pump	
Air Conditioner	
Tube Light	
Fan	
Roof Light	
Bulb	

AREA	
AREA WITHIN BOUNDARY WALL	79821.909 Sft
AREA OF CLINICAL BLOCK	17200.118 Sft
PLINTH AREA OF BLOCK	15247.951 Sft

OPENING SCHEDULE OF DOORS AND WINDOWS					
DOORS	WIDTH	HEIGHT	WINDOWS	WIDTH	HEIGHT
D1	2'-0"	7'-0"	W1	3'-0"	5'-0"
D2	2'-6"	7'-0"	W2	4'-0"	4'-0"
D3	3'-0"	7'-0"	W3	6'-0"	6'-0"
D4	3'-6"	7'-0"	W4	8'-0"	8'-0"
D5	4'-0"	7'-0"	W5	5'-0"	5'-0"
D6	4'-6"	7'-0"	W6	8'-0"	8'-0"
D7	5'-0"	7'-0"	W7	2'-0"	2'-0"
D8	6'-0"	7'-0"	V1	2'-0"	2'-0"
D9	7'-0"	7'-0"	V2		

Project:
**CAD MAPPING OF TEHSIL
HEAD QUARTER HOSPITALS,
PUNJAB**



Client: GOVERNMENT OF THE PUNJAB PRIMARY & SECONDARY HEALTHCARE DEPARTMENT	Consultant: SKAFS CONSULTANT (Pvt.) Limited ENGINEERING AND ENVIRONMENT CONSULTANT
---	--

Drawing Title:
**THQ MURREE
HOSPITAL MASTER PLAN**

Drawing No.
SKAFS/MURREE /03

MASTER PLAN OF THQ HOSPITAL MURREE

PART 1

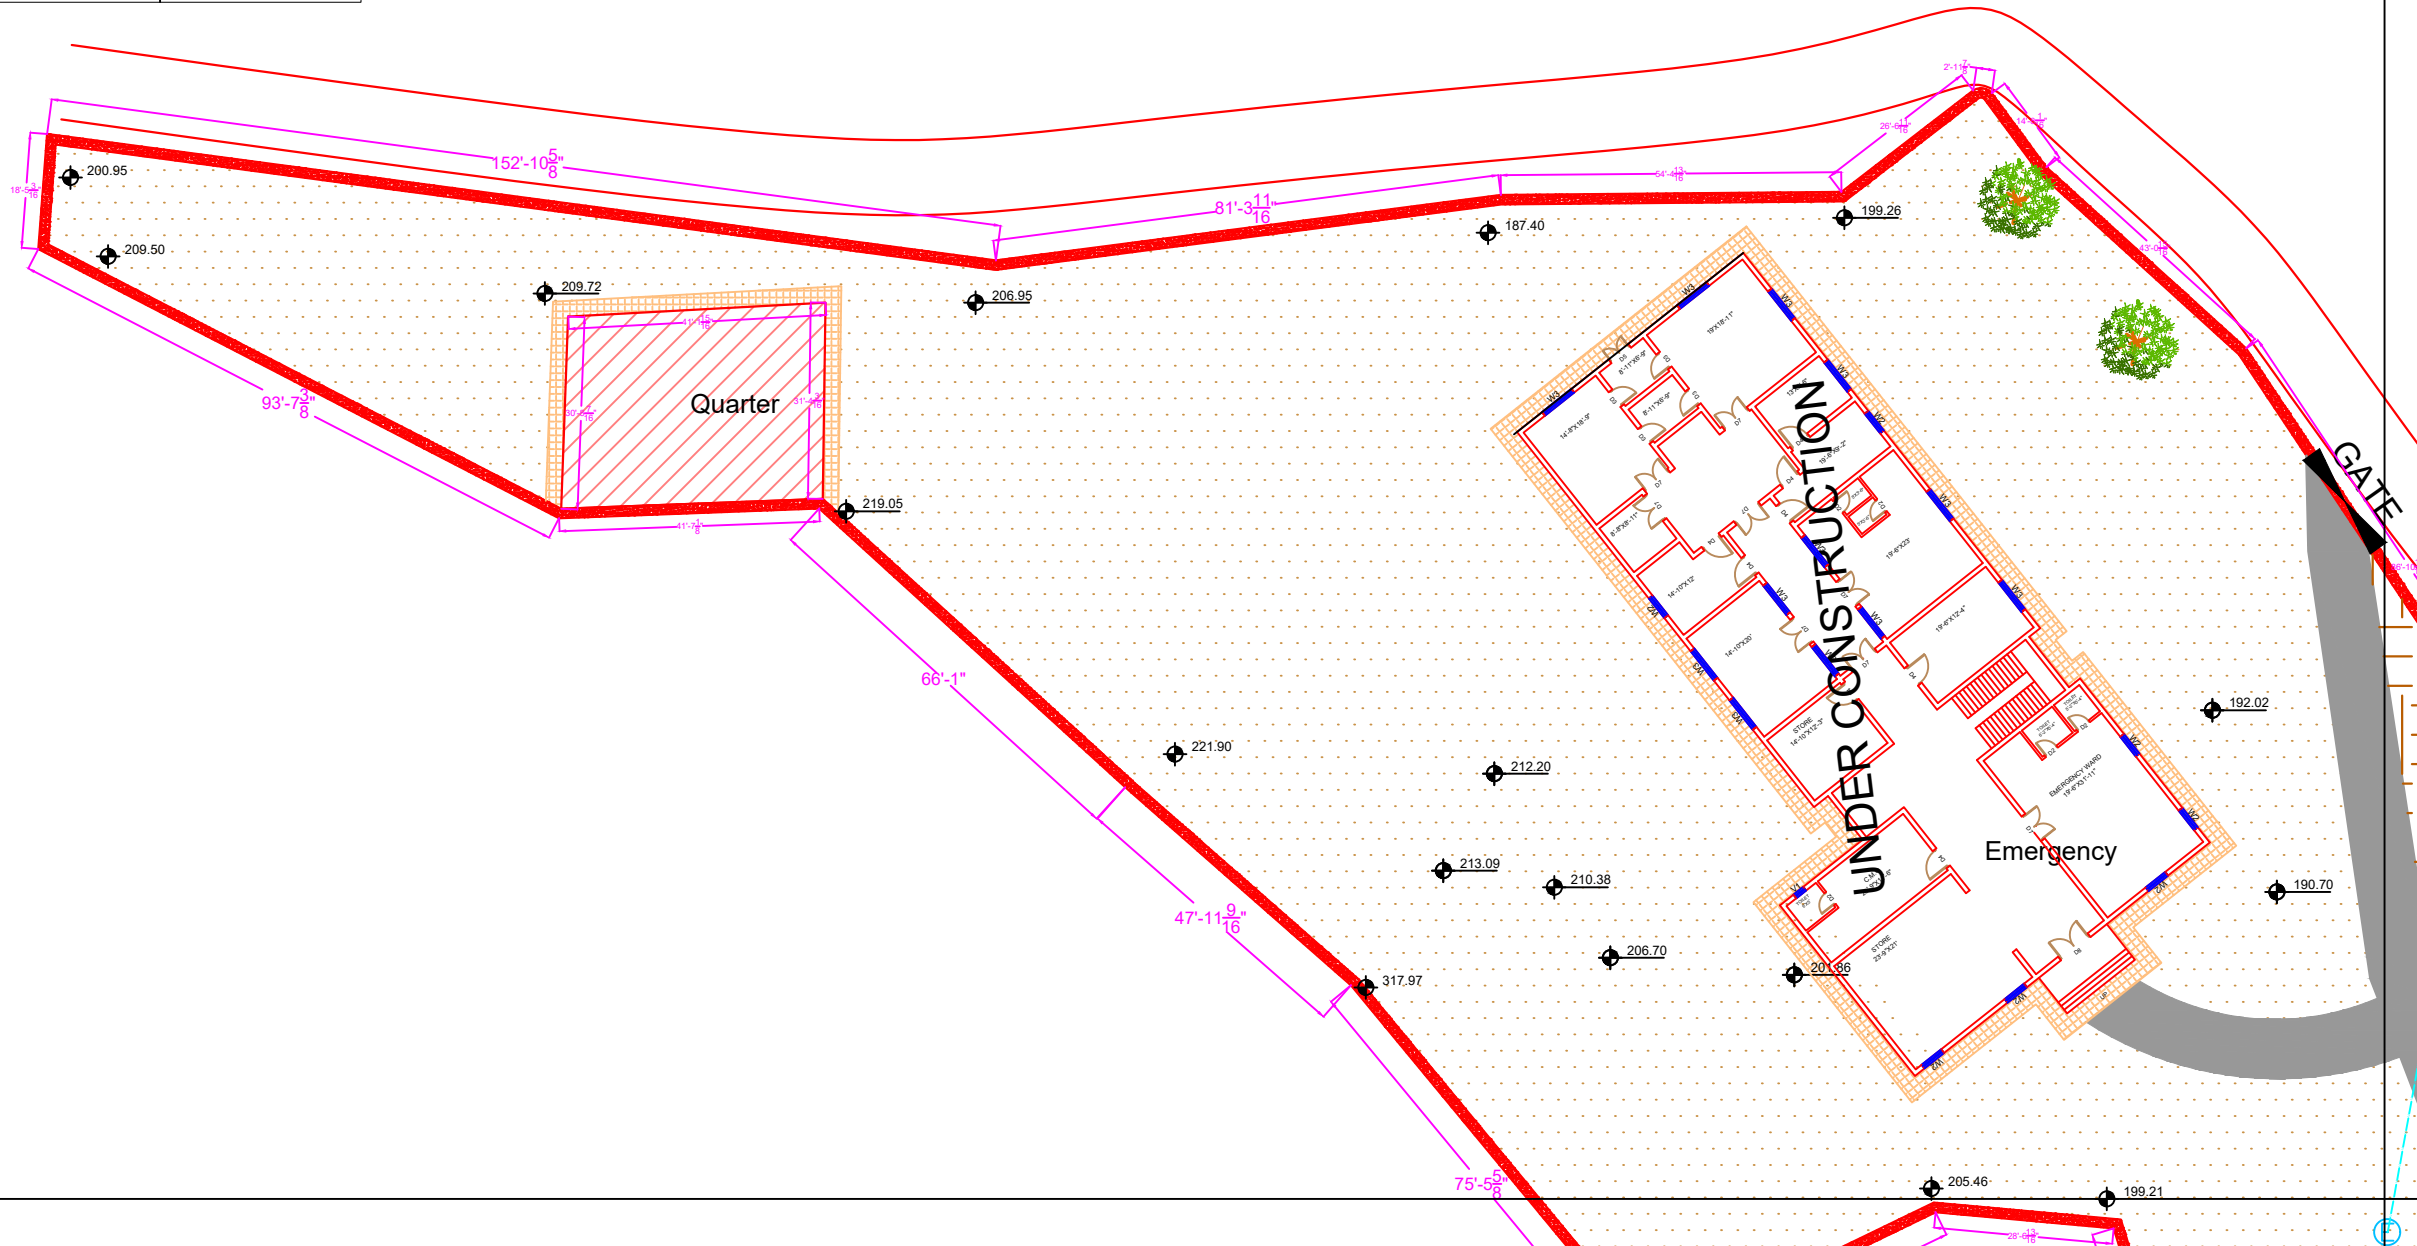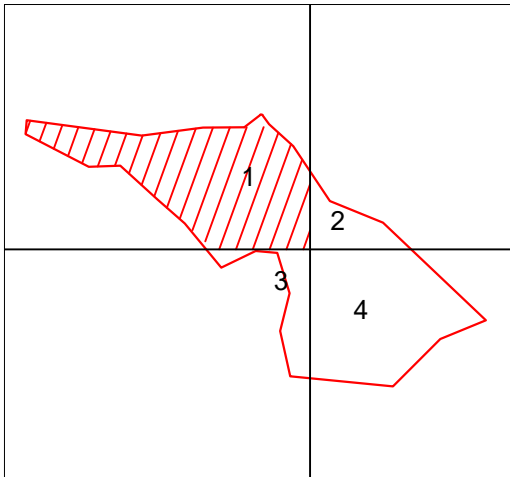

Legends:

Residential Area	
Road	
Wall	
Power Line	
OHT	
Tree	
Man Hole	
Tube Well	
Light Pole	
Lawns	
Earthen Areas	
Asphalts Roads	
Tough Pavers	
P.C.C / Plinth Protection	
Boundary Wall	
Brick Pavers / Soling	
Drain	
Tap	
Hand Pump	
Air Conditioner	
Tube Light	
Fan	
Roof Light	
Bulb	

AREA	
AREA WITHIN BOUNDARY WALL	79821.909 Sft
AREA OF CLINICAL BLOCK	17200.118 Sft
PLINTH AREA OF BLOCK	15247.951 Sft

OPENING SCHEDULE OF DOORS AND WINDOWS					
DOORS	WIDTH	HEIGHT	WINDOWS	WIDTH	HEIGHT
D1	2'-0"	7'-0"	W1	3'-0"	5'-0"
D2	2'-6"	7'-0"	W2	4'-0"	4'-0"
D3	3'-0"	7'-0"	W3	6'-0"	6'-0"
D4	3'-6"	7'-0"	W4	8'-0"	8'-0"
D5	4'-0"	7'-0"	W5	5'-0"	5'-0"
D6	4'-6"	7'-0"	W6	8'-0"	8'-0"
D7	5'-0"	7'-0"	W7	2'-0"	2'-0"
D8	6'-0"	7'-0"	V1	2'-0"	2'-0"
D9	7'-0"	7'-0"	V2		

Project:
**CAD MAPPING OF TEHSIL
HEAD QUARTER HOSPITALS,
PUNJAB**




Client: GOVERNMENT OF THE PUNJAB PRIMARY & SECONDARY HEALTHCARE DEPARTMENT	Consultant: SKAFS CONSULTANT (Pvt.) Limited ENGINEERING AND ENVIRONMENT CONSULTANT
---	--

Drawing Title:
**THQ MURREE
HOSPITAL MASTER PLAN PART 1**

Drawing No.
SKAFS/MURREE /04

MASTER PLAN OF THQ HOSPITAL MURREE

PART 2

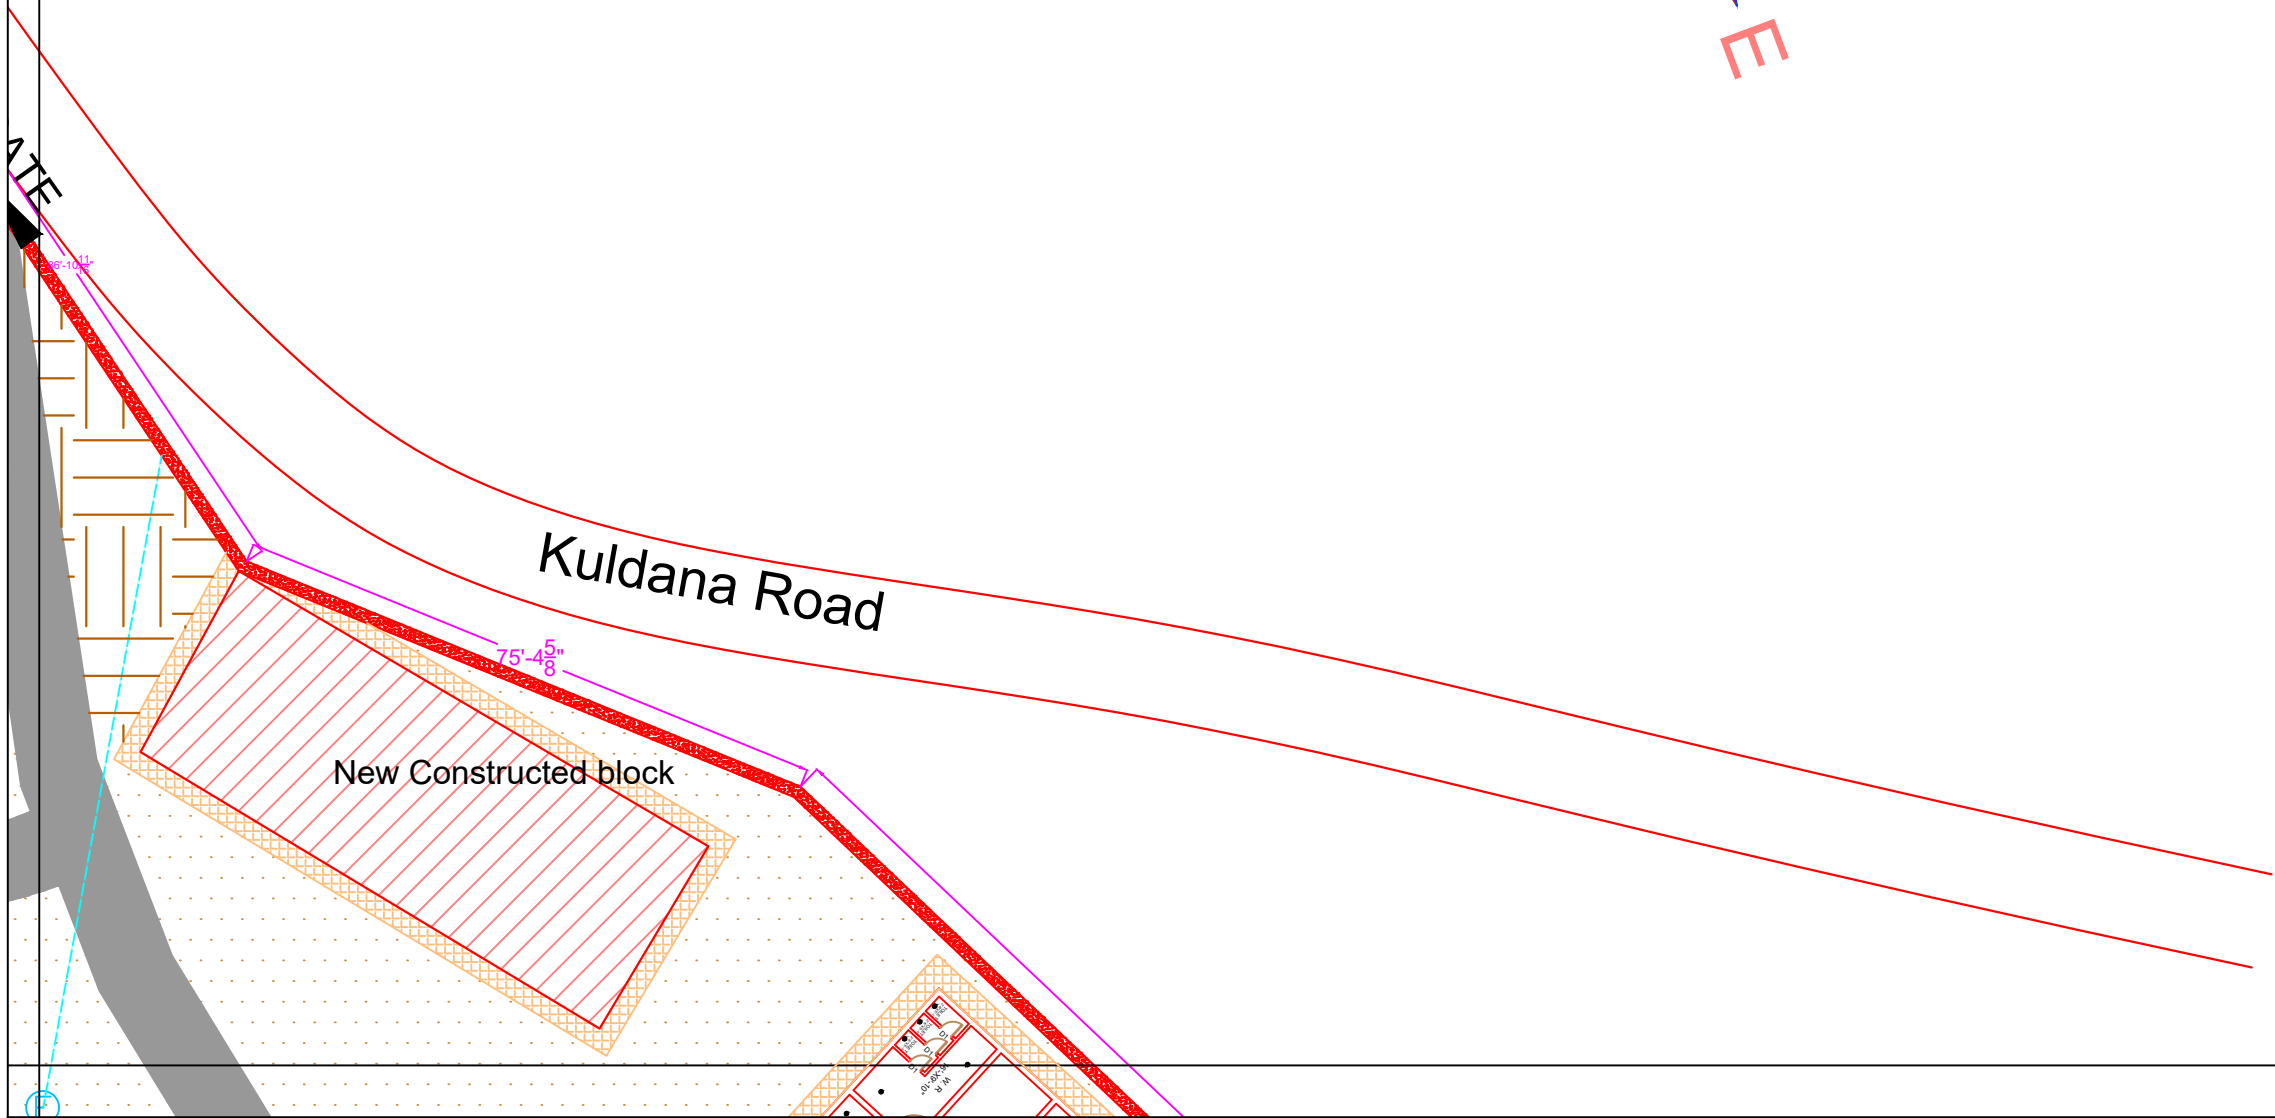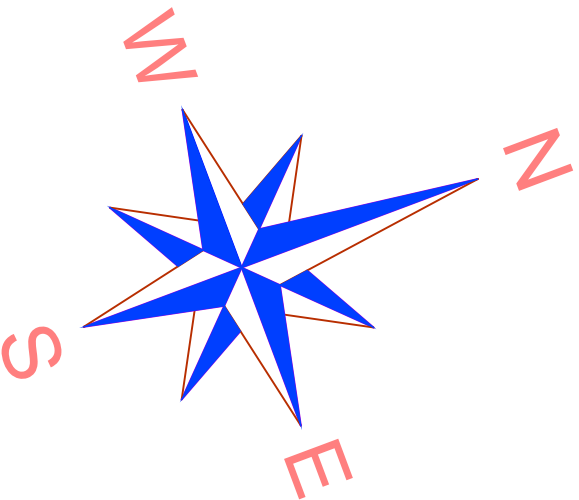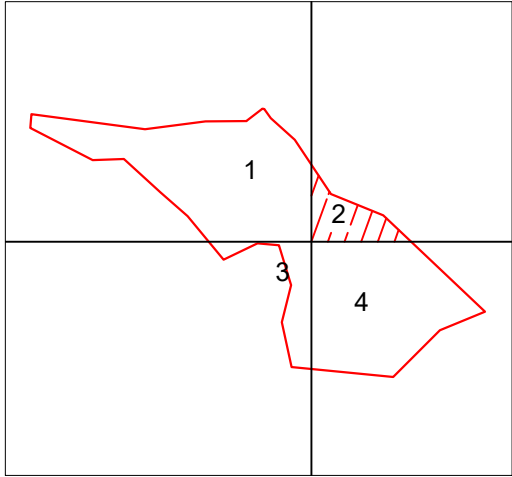

Legends:

Residential Area	
Road	
Wall	
Power Line	
OHT	
Tree	
Man Hole	
Tube Well	
Light Pole	
Lawns	
Earthen Areas	
Asphalts Roads	
Tough Pavers	
P.C.C / Plinth Protection	
Boundary Wall	
Brick Pavers / Soling	
Drain	
Tap	
Hand Pump	
Air Conditioner	
Tube Light	
Fan	
Roof Light	
Bulb	

AREA	
AREA WITHIN BOUNDARY WALL	79821.909 Sft
AREA OF CLINICAL BLOCK	17200.118 Sft
PLINTH AREA OF BLOCK	15247.951 Sft

OPENING SCHEDULE OF DOORS AND WINDOWS					
DOORS	WIDTH	HEIGHT	WINDOWS	WIDTH	HEIGHT
D1	2'-0"	7'-0"	W1	3'-0"	5'-0"
D2	2'-6"	7'-0"	W2	4'-0"	4'-0"
D3	3'-0"	7'-0"	W3	6'-0"	6'-0"
D4	3'-6"	7'-0"	W4	8'-0"	8'-0"
D5	4'-0"	7'-0"	W5	5'-0"	5'-0"
D6	4'-6"	7'-0"	W6	8'-0"	8'-0"
D7	5'-0"	7'-0"	W7	2'-0"	2'-0"
D8	6'-0"	7'-0"	V1	2'-0"	2'-0"
D9	7'-0"	7'-0"	V2		

Project:
**CAD MAPPING OF TEHSIL
HEAD QUARTER HOSPITALS,
PUNJAB**


Client: GOVERNMENT OF THE PUNJAB PRIMARY & SECONDARY HEALTHCARE DEPARTMENT	Consultant: SKAFS CONSULTANT (Pvt.) Limited ENGINEERING AND ENVIRONMENT CONSULTANT
---	--

Drawing Title: **THQ MURREE
HOSPITAL MASTER PLAN PART 2**

Drawing No. **SKAFS/MURREE /05**



MASTER PLAN OF THQ HOSPITAL MURREE

PART 3

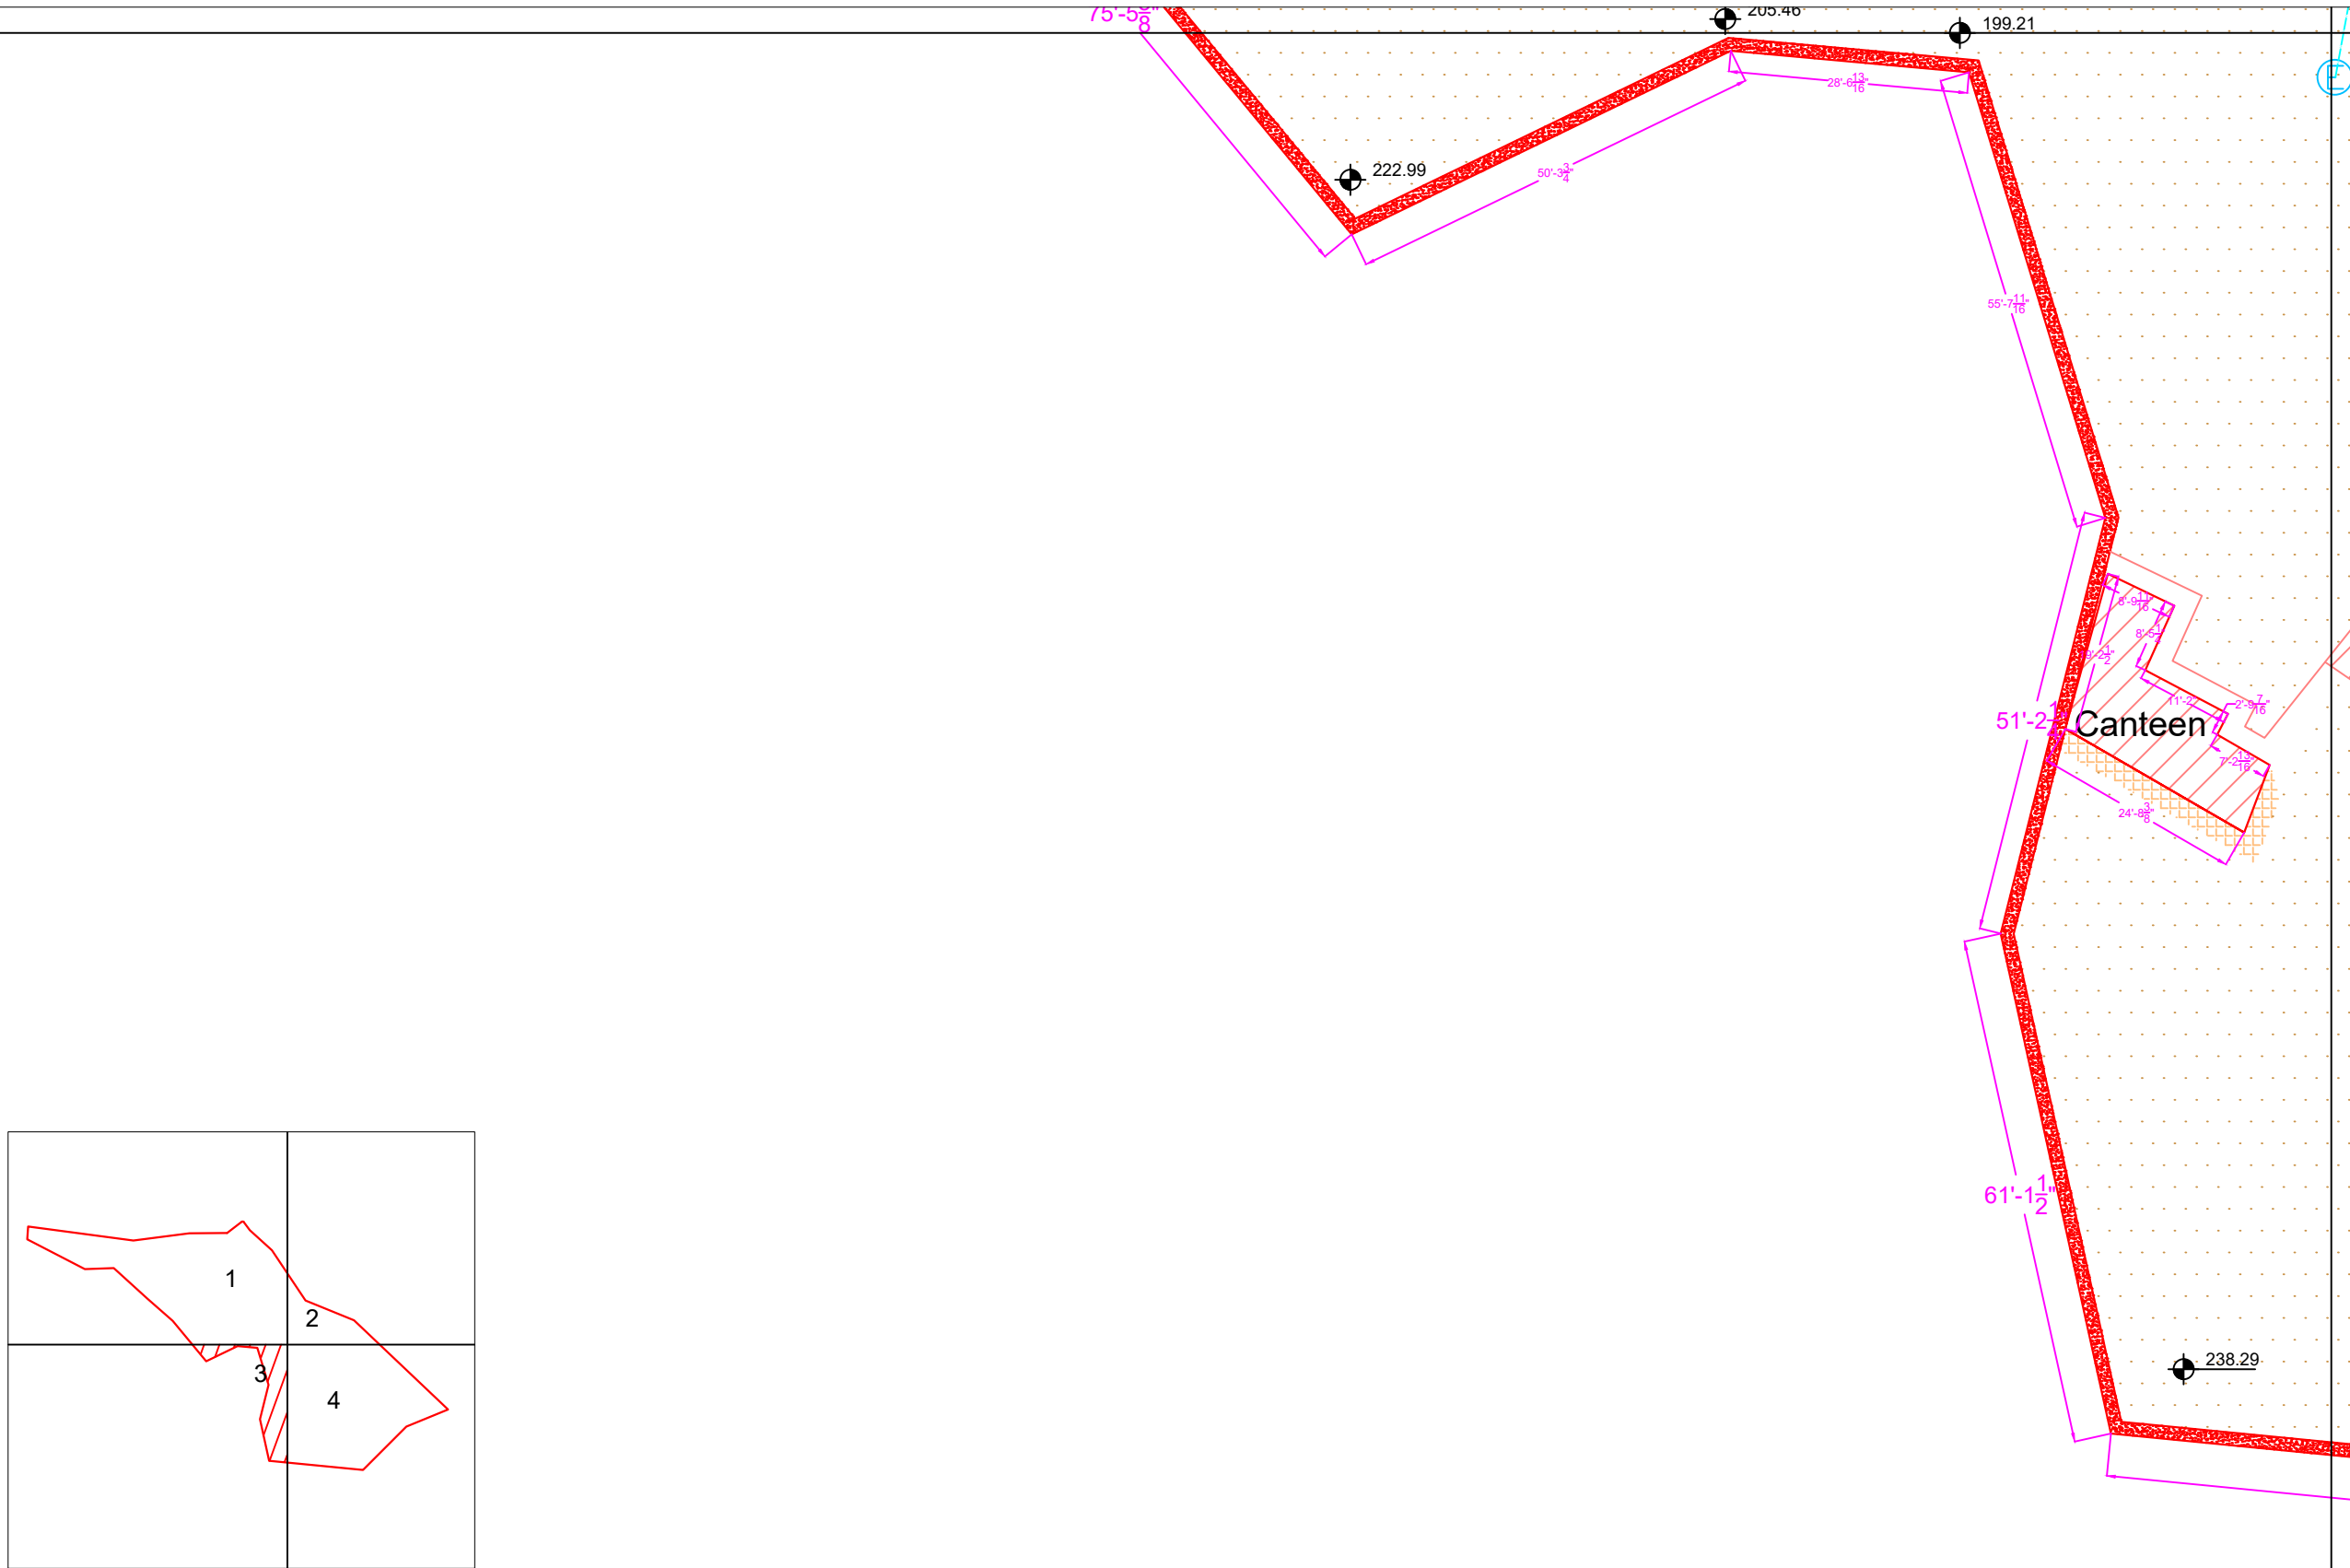

MASTER PLAN OF THQ HOSPITAL MURREE

PART 4

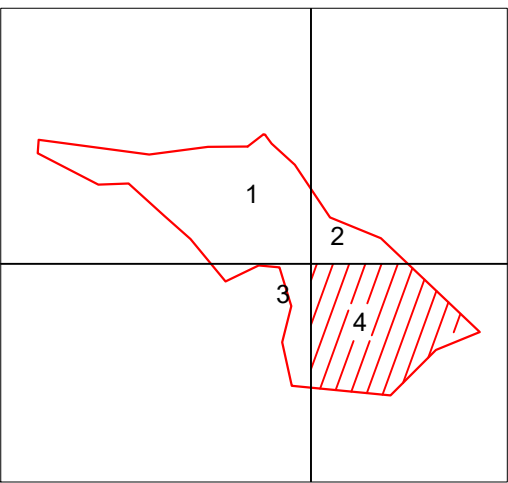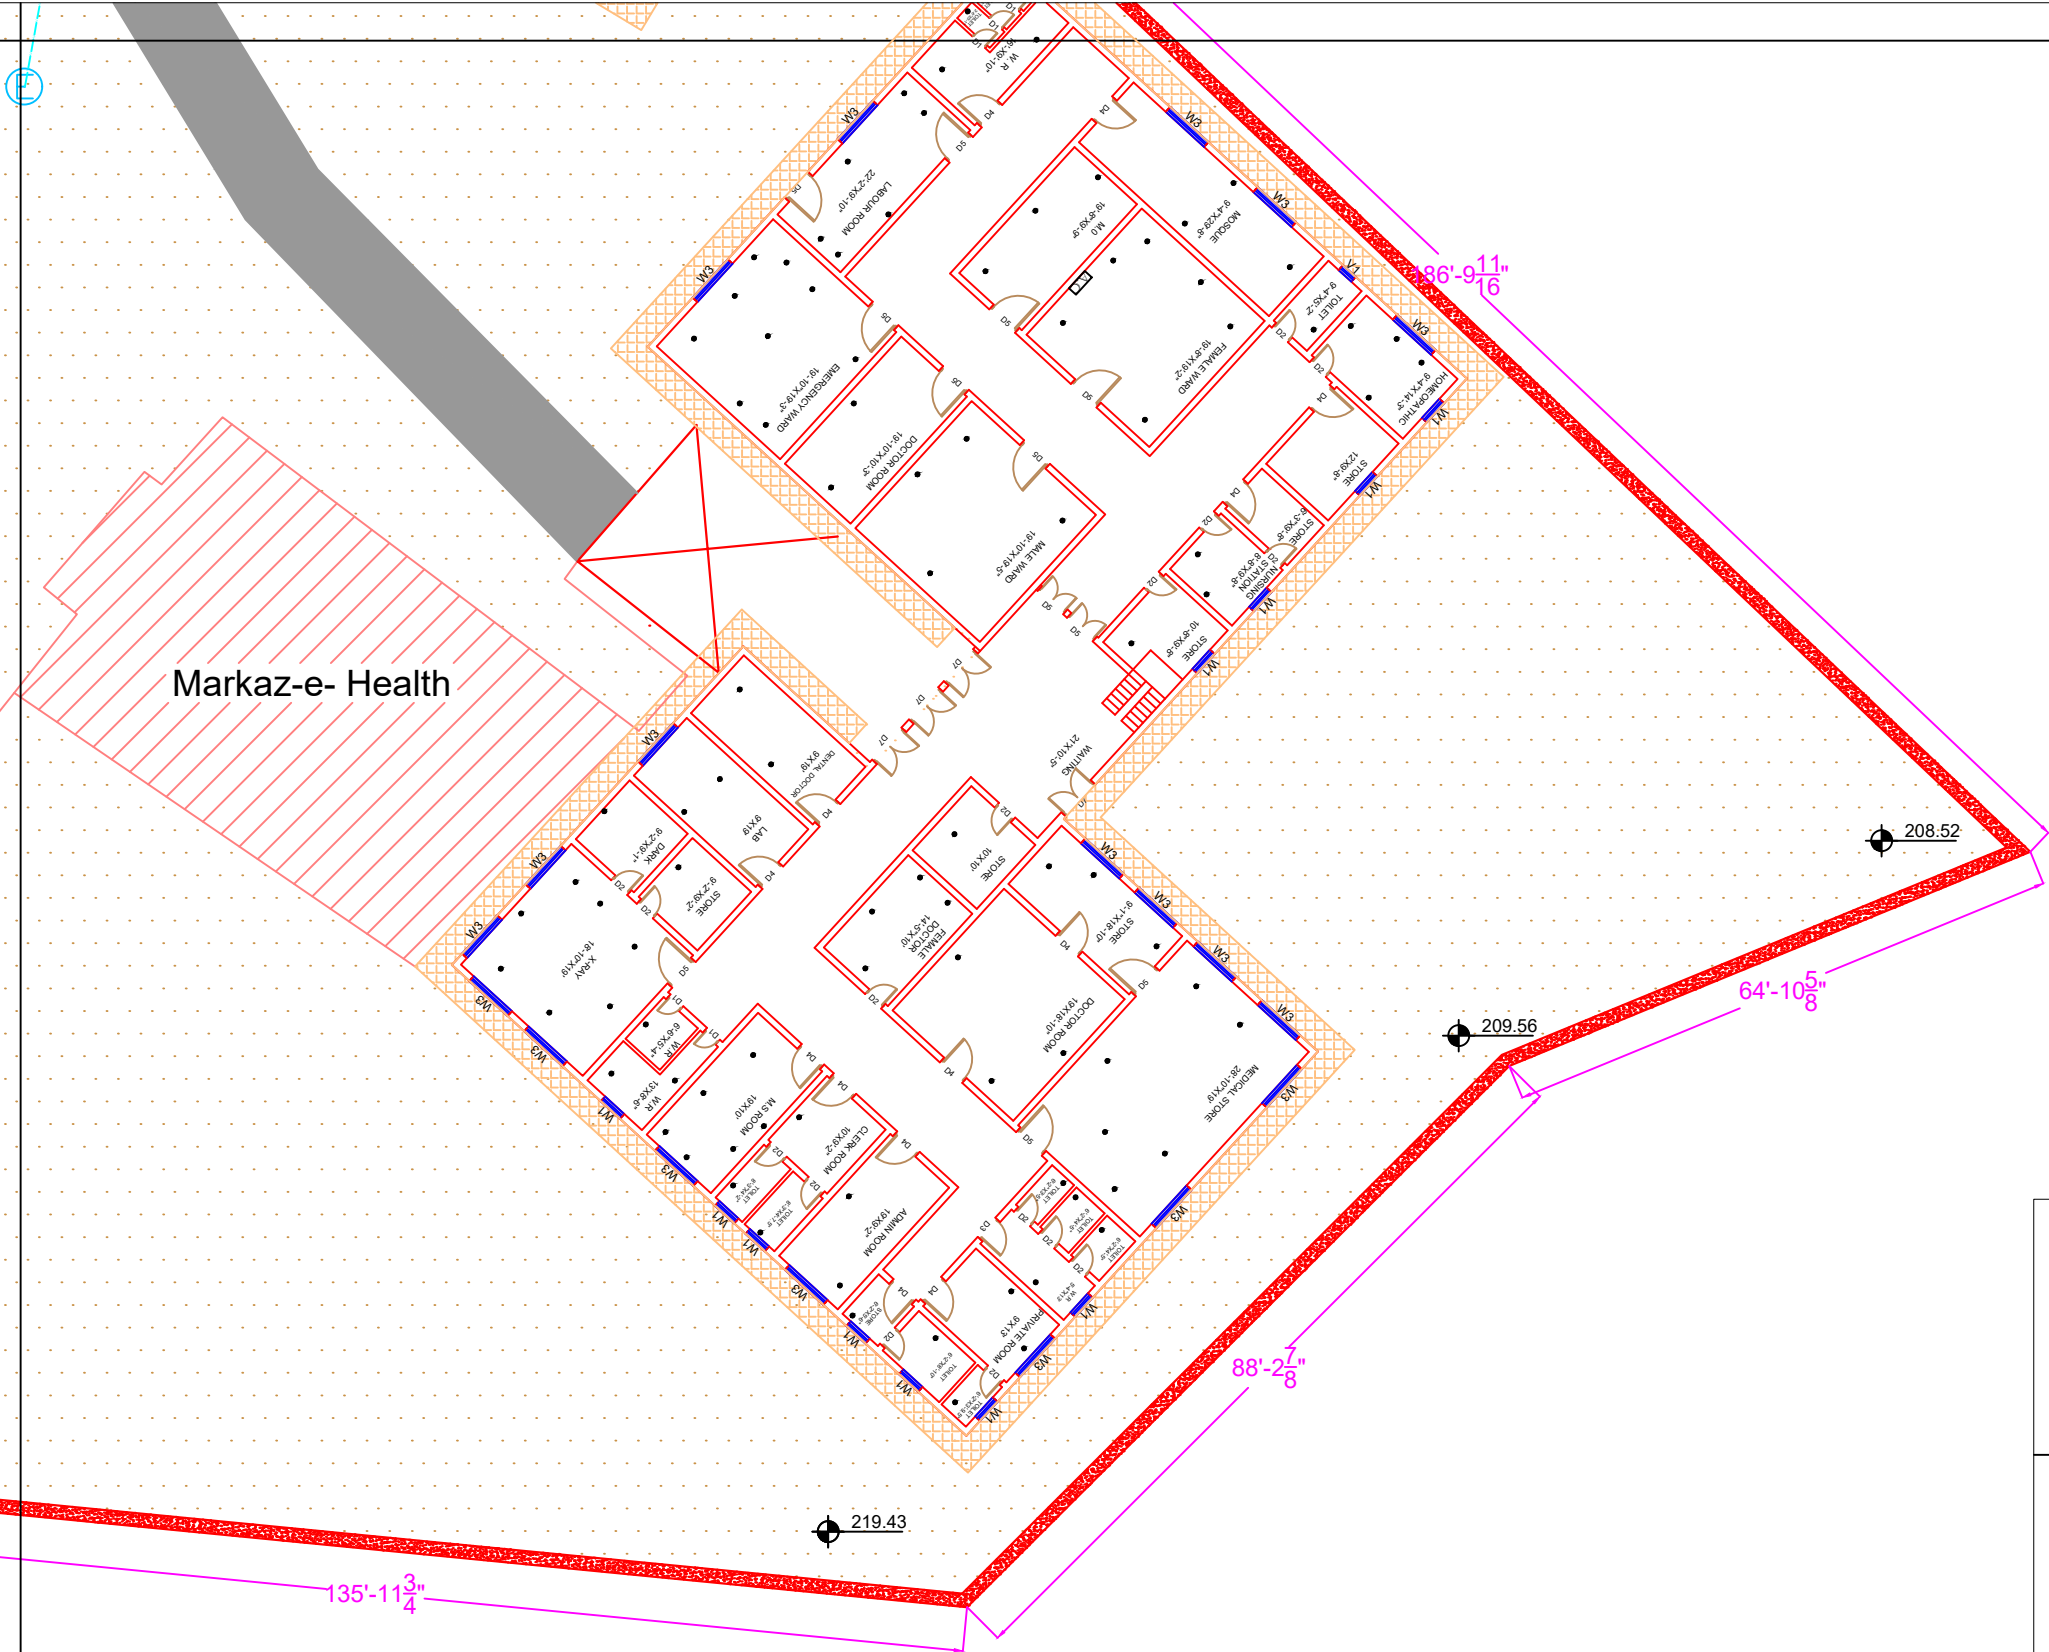

Legends:	
Residential Area	
Road	
Wall	
Power Line	
OHT	
Tree	
Man Hole	
Tube Well	
Light Pole	
Lawns	
Earthen Areas	
Asphalts Roads	
Tough Pavers	
P.C.C / Plinth Protection	
Boundary Wall	
Brick Pavers / Soling	
Drain	
Tap	
Hand Pump	
Air Conditioner	
Tube Light	
Fan	
Roof Light	
Bulb	

AREA	
AREA WITHIN BOUNDARY WALL	79821.909 Sft
AREA OF CLINICAL BLOCK	17200.118 Sft
PLINTH AREA OF BLOCK	15247.951 Sft

OPENING SCHEDULE OF DOORS AND WINDOWS					
DOORS	WIDTH	HEIGHT	WINDOWS	WIDTH	HEIGHT
D1	2'-0"	7'-0"	W1	3'-0"	5'-0"
D2	2'-6"	7'-0"	W2	4'-0"	4'-0"
D3	3'-0"	7'-0"	W3	6'-0"	6'-0"
D4	3'-6"	7'-0"	W4	8'-0"	8'-0"
D5	4'-0"	7'-0"	W5	5'-0"	5'-0"
D6	4'-6"	7'-0"	W6	8'-0"	8'-0"
D7	5'-0"	7'-0"	W7	2'-0"	2'-0"
D8	6'-0"	7'-0"	V1	2'-0"	2'-0"
D9	7'-0"	7'-0"	V2		



Project:
**CAD MAPPING OF TEHSIL
HEAD QUARTER HOSPITALS,
PUNJAB**

Client: GOVERNMENT OF THE PUNJAB PRIMARY & SECONDARY HEALTHCARE DEPARTMENT	Consultant: SKAFS CONSULTANT (Pvt.) Limited ENGINEERING AND ENVIRONMENT CONSULTANT
---	--

Drawing Title:
**THQ MURREE
HOSPITAL MASTER PLAN PART 4**

Drawing No.
SKAFS/MURREE /07

CLINICAL BLOCK OF THQ HOSPITAL MURREE
GROUND FLOOR

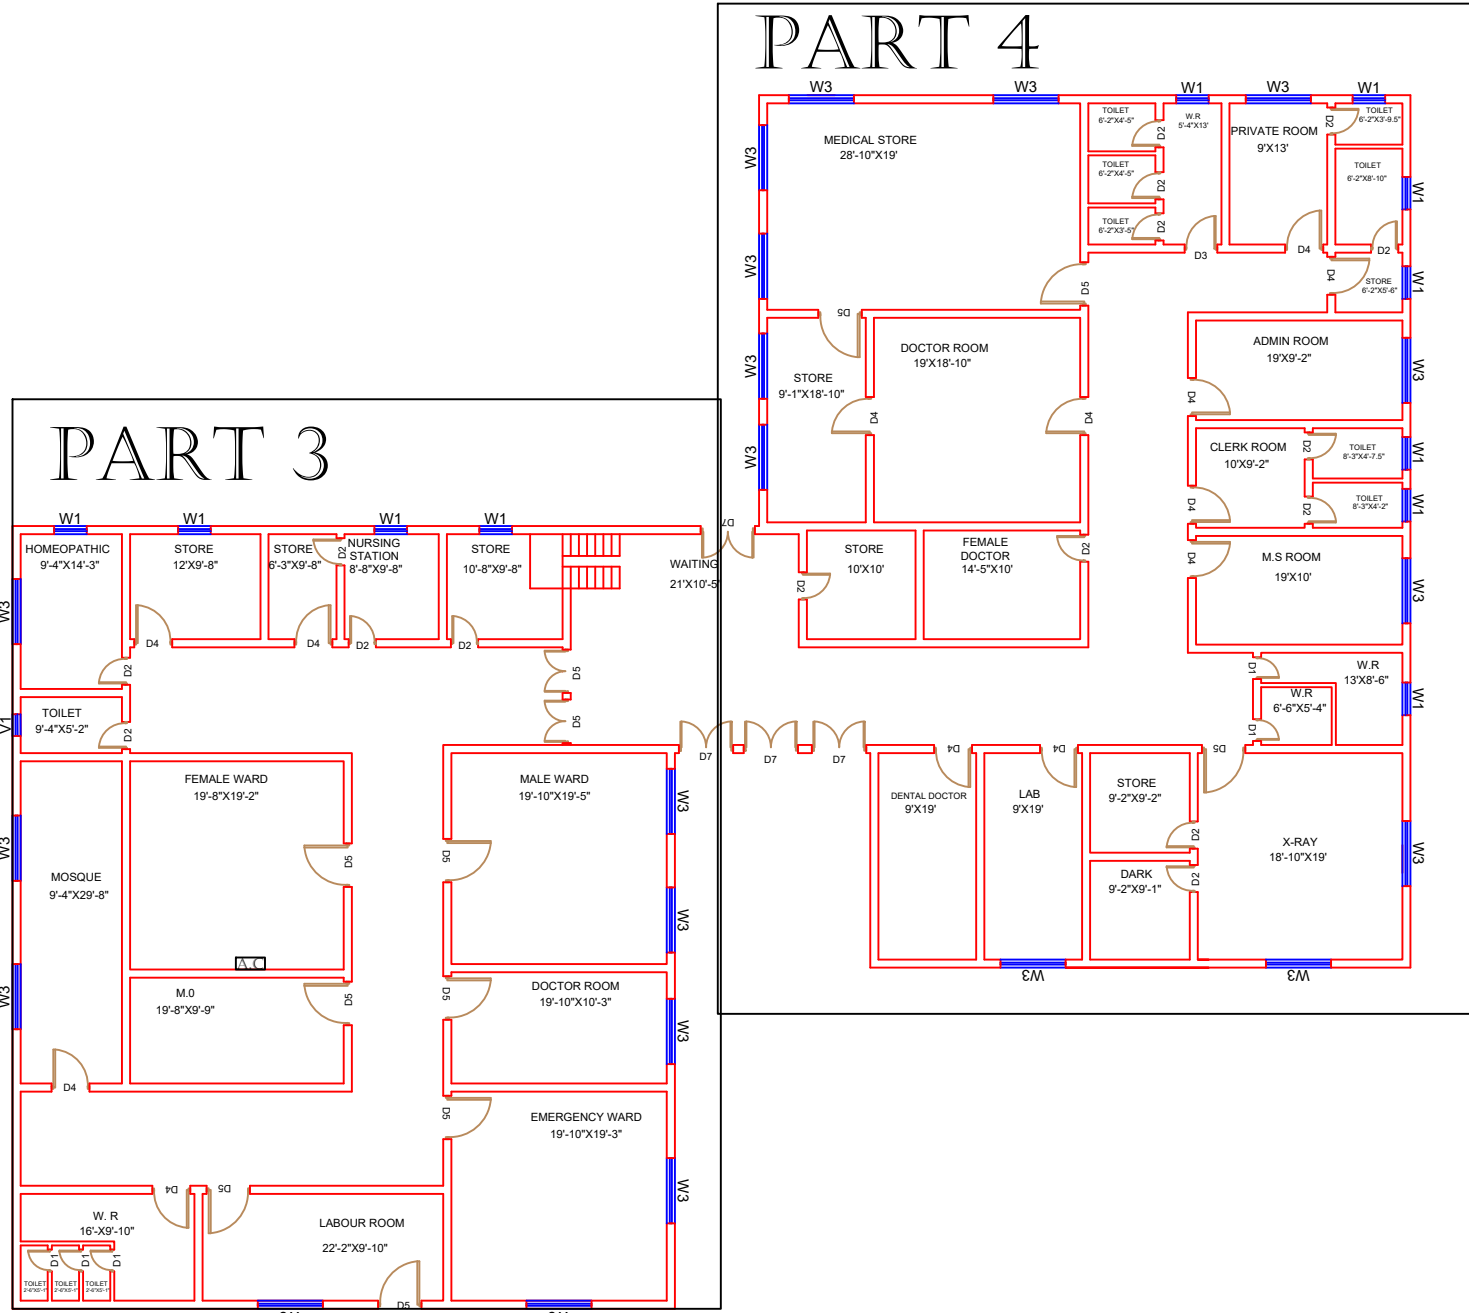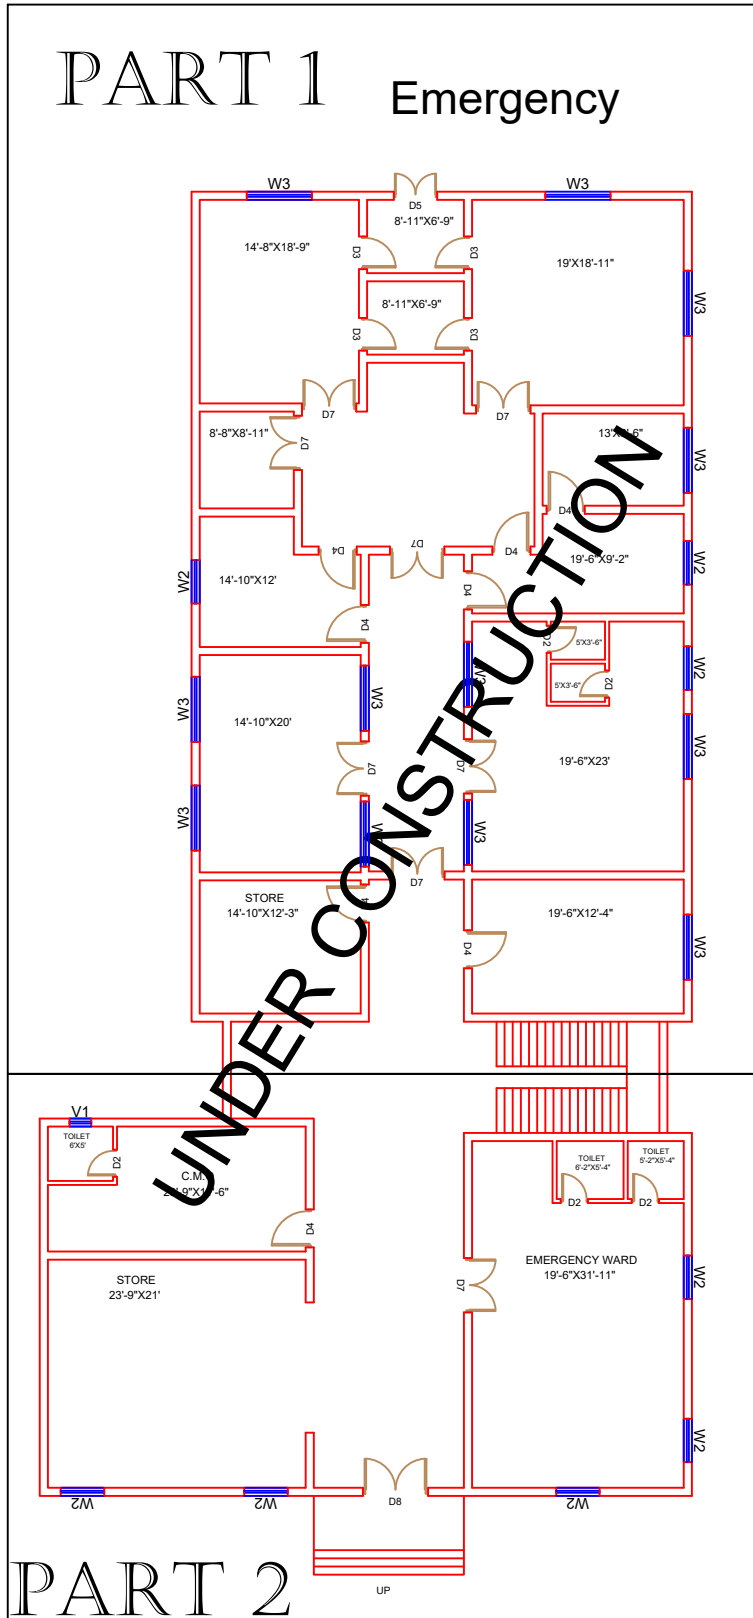

Legends:

Residential Area	
Road	
Wall	
Power Line	
OHT	
Tree	
Man Hole	
Tube Well	
Light Pole	
Lawns	
Earthen Areas	
Asphalts Roads	
Tough Pavers	
P.C.C / Plinth Protection	
Boundary Wall	
Brick Pavers / Soling	
Drain	
Tap	
Hand Pump	
Air Conditioner	
Tube Light	
Fan	
Roof Light	
Bulb	

AREA	
AREA WITHIN BOUNDARY WALL	79821.909 Sft
AREA OF CLINICAL BLOCK	17200.118 Sft
PLINTH AREA OF BLOCK	15247.951 Sft

DOORS	WIDTH	HEIGHT	WINDOWS	WIDTH	HEIGHT
D1	2'-0"	7'-0"	W1	3'-0"	5'-0"
D2	2'-6"	7'-0"	W2	4'-0"	4'-0"
D3	3'-0"	7'-0"	W3	6'-0"	6'-0"
D4	3'-6"	7'-0"	W4	8'-0"	8'-0"
D5	4'-0"	7'-0"	W5	5'-0"	5'-0"
D6	4'-6"	7'-0"	W6	8'-0"	8'-0"
D7	5'-0"	7'-0"	W7	2'-0"	2'-0"
D8	6'-0"	7'-0"	V1	2'-0"	2'-0"
D9	7'-0"	7'-0"	V2		

Project: **CAD MAPPING OF TEHSIL
HEAD QUARTER HOSPITALS,
PUNJAB**


Client:  GOVERNMENT OF THE PUNJAB PRIMARY & SECONDARY HEALTHCARE DEPARTMENT	Consultant:  SKAFS CONSULTANT (Pvt.) Limited <i>ENGINEERING AND ENVIRONMENT</i>
--	--

Drawing Title: **THQ MURREE
HOSPITAL CLINICAL BLOCK PLAN**

Drawing No. SKAFS/MURREE /08

CLINICAL BLOCK OF THQ HOSPITAL MURREE

GROUND FLOOR PART 1

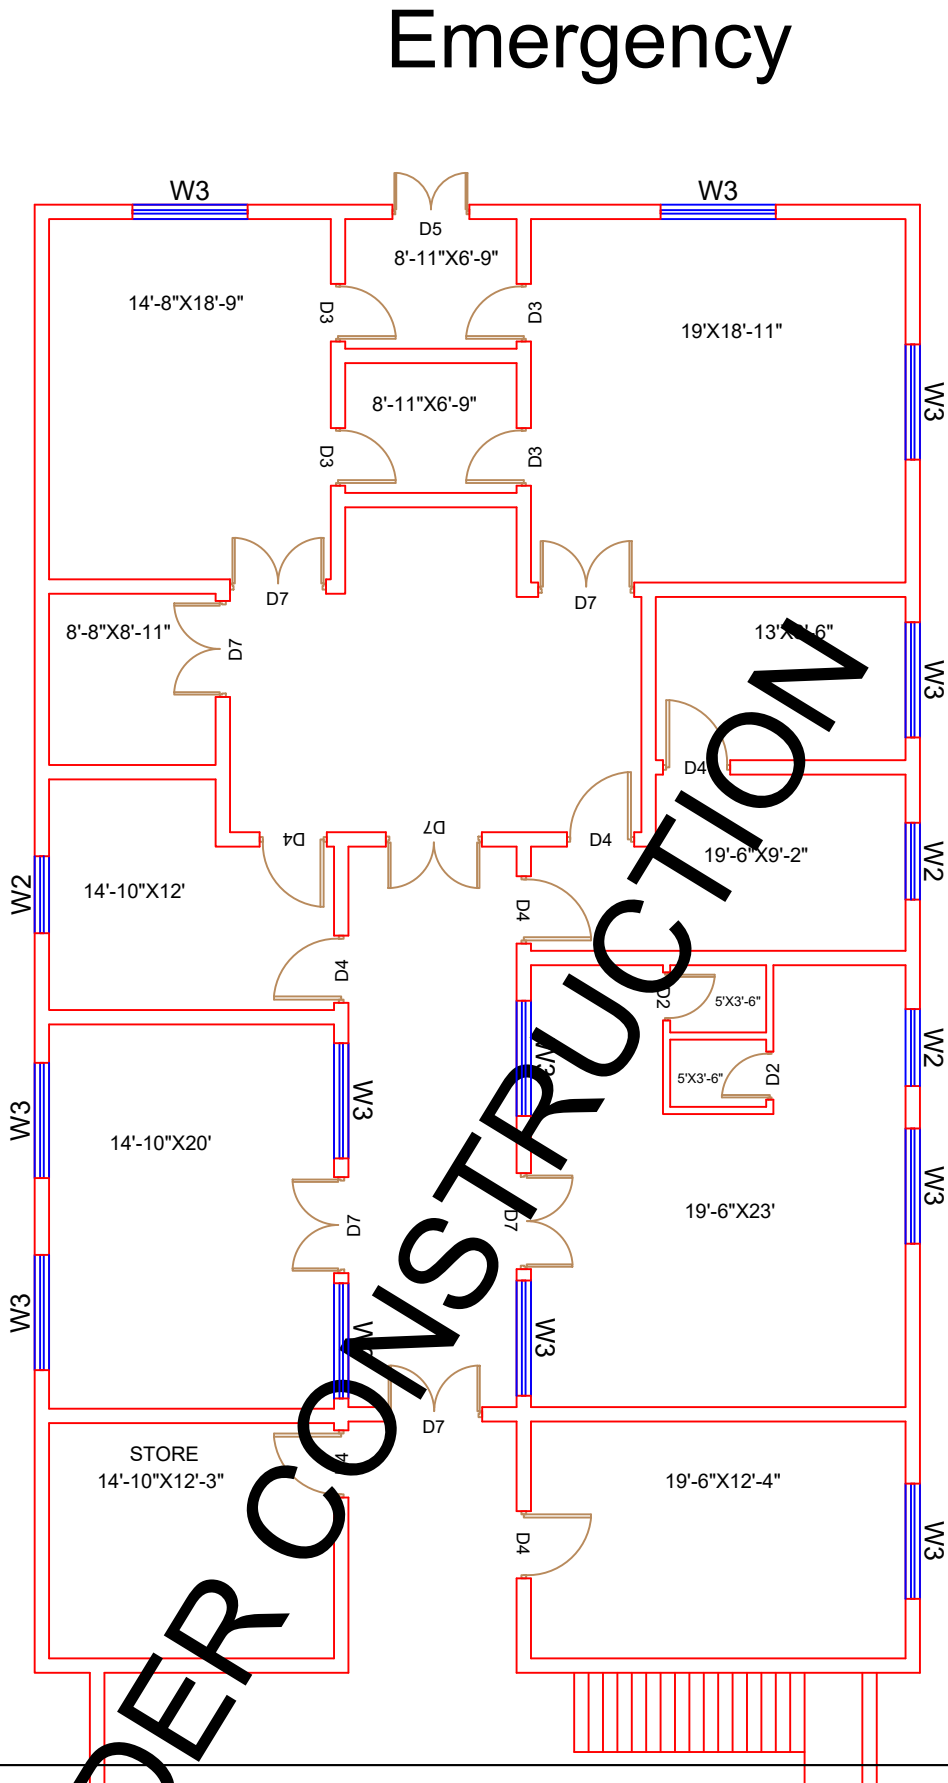

Legends:

Residential Area	
Road	
Wall	
Power Line	
OHT	
Tree	
Man Hole	
Tube Well	
Light Pole	
Lawns	
Earthen Areas	
Asphalts Roads	
Tough Pavers	
P.C.C / Plinth Protection	
Boundary Wall	
Brick Pavers / Soling	
Drain	
Tap	
Hand Pump	
Air Conditioner	
Tube Light	
Fan	
Roof Light	
Bulb	

AREA	
AREA WITHIN BOUNDARY WALL	79821.909 Sft
AREA OF CLINICAL BLOCK	17200.118 Sft
PLINTH AREA OF BLOCK	15247.951 Sft

OPENING SCHEDULE OF DOORS AND WINDOWS					
DOORS	WIDTH	HEIGHT	WINDOWS	WIDTH	HEIGHT
D1	2'-0"	7'-0"	W1	3'-0"	5'-0"
D2	2'-6"	7'-0"	W2	4'-0"	4'-0"
D3	3'-0"	7'-0"	W3	6'-0"	6'-0"
D4	3'-6"	7'-0"	W4	8'-0"	8'-0"
D5	4'-0"	7'-0"	W5	5'-0"	5'-0"
D6	4'-6"	7'-0"	W6	8'-0"	8'-0"
D7	5'-0"	7'-0"	W7	2'-0"	2'-0"
D8	6'-0"	7'-0"	V1	2'-0"	2'-0"
D9	7'-0"	7'-0"	V2		

Project:
CAD MAPPING OF TEHSIL HEAD QUARTER HOSPITALS, PUNJAB


Client: GOVERNMENT OF THE PUNJAB PRIMARY & SECONDARY HEALTHCARE DEPARTMENT	Consultant: SKAFS CONSULTANT (Pvt.) Limited ENGINEERING AND ENVIRONMENT CONSULTANT
---	--

Drawing Title: **THQ MURREE CLINICAL BLOCK PLAN (PART 1)**

Drawing No. **SKAFS/MURREE /09**

CLINICAL BLOCK OF THQ HOSPITAL MURREE

GROUND FLOOR PART 2

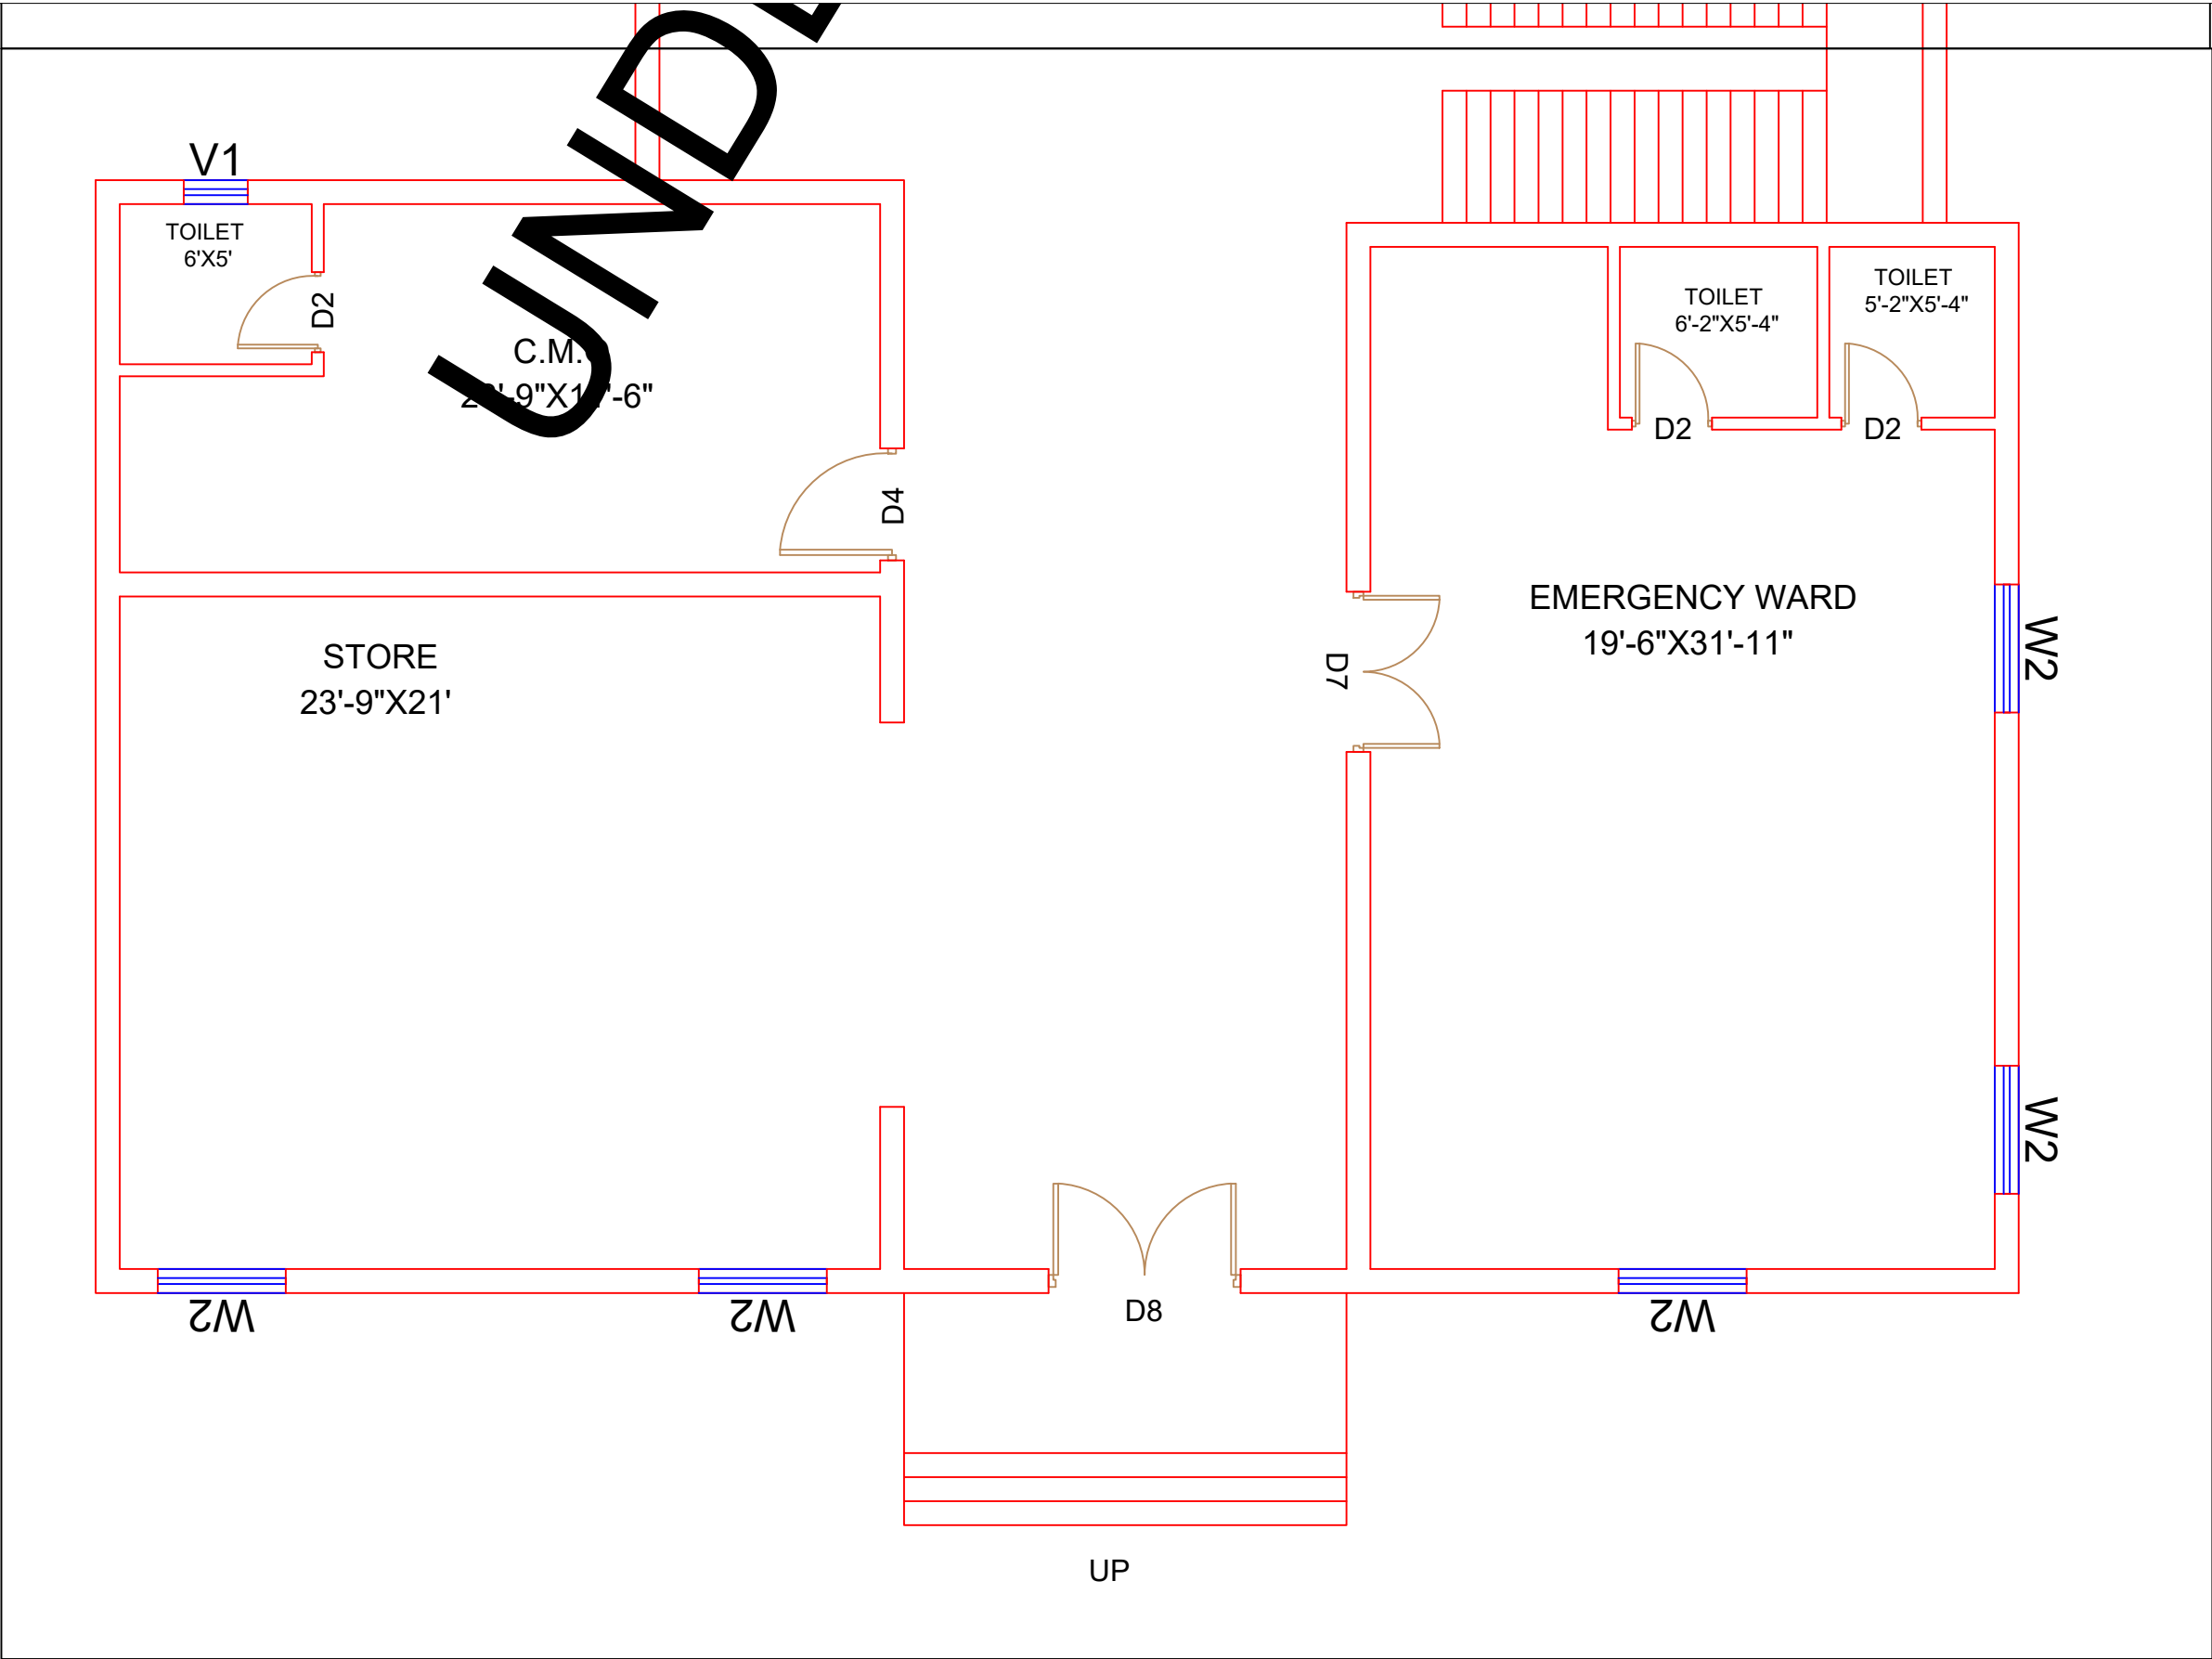

Legends:

Residential Area	
Road	
Wall	
Power Line	
OHT	
Tree	
Man Hole	
Tube Well	
Light Pole	
Lawns	
Earthen Areas	
Asphalts Roads	
Tough Pavers	
P.C.C / Plinth Protection	
Boundary Wall	
Brick Pavers / Soling	
Drain	
Tap	
Hand Pump	
Air Conditioner	
Tube Light	
Fan	
Roof Light	
Bulb	

AREA	
AREA WITHIN BOUNDARY WALL	79821.909 Sft
AREA OF CLINICAL BLOCK	17200.118 Sft
PLINTH AREA OF BLOCK	15247.951 Sft

OPENING SCHEDULE OF DOORS AND WINDOWS					
DOORS	WIDTH	HEIGHT	WINDOWS	WIDTH	HEIGHT
D1	2'-0"	7'-0"	W1	3'-0"	5'-0"
D2	2'-6"	7'-0"	W2	4'-0"	4'-0"
D3	3'-0"	7'-0"	W3	6'-0"	6'-0"
D4	3'-6"	7'-0"	W4	8'-0"	8'-0"
D5	4'-0"	7'-0"	W5	5'-0"	5'-0"
D6	4'-6"	7'-0"	W6	8'-0"	8'-0"
D7	5'-0"	7'-0"	W7	2'-0"	2'-0"
D8	6'-0"	7'-0"	V1	2'-0"	2'-0"
D9	7'-0"	7'-0"	V2		

Project:
**CAD MAPPING OF TEHSIL
HEAD QUARTER HOSPITALS,
PUNJAB**


Client: GOVERNMENT OF THE PUNJAB PRIMARY & SECONDARY HEALTHCARE DEPARTMENT	Consultant: SKAFS CONSULTANT (Pvt.) Limited ENGINEERING AND ENVIRONMENT CONSULTANT
---	--

Drawing Title: **THQ MURREE
CLINICAL BLOCK PLAN (PART 2)**

Drawing No. **SKAFS/MURREE /10**

CLINICAL BLOCK OF THQ HOSPITAL MURREE

GROUND FLOOR PART 3

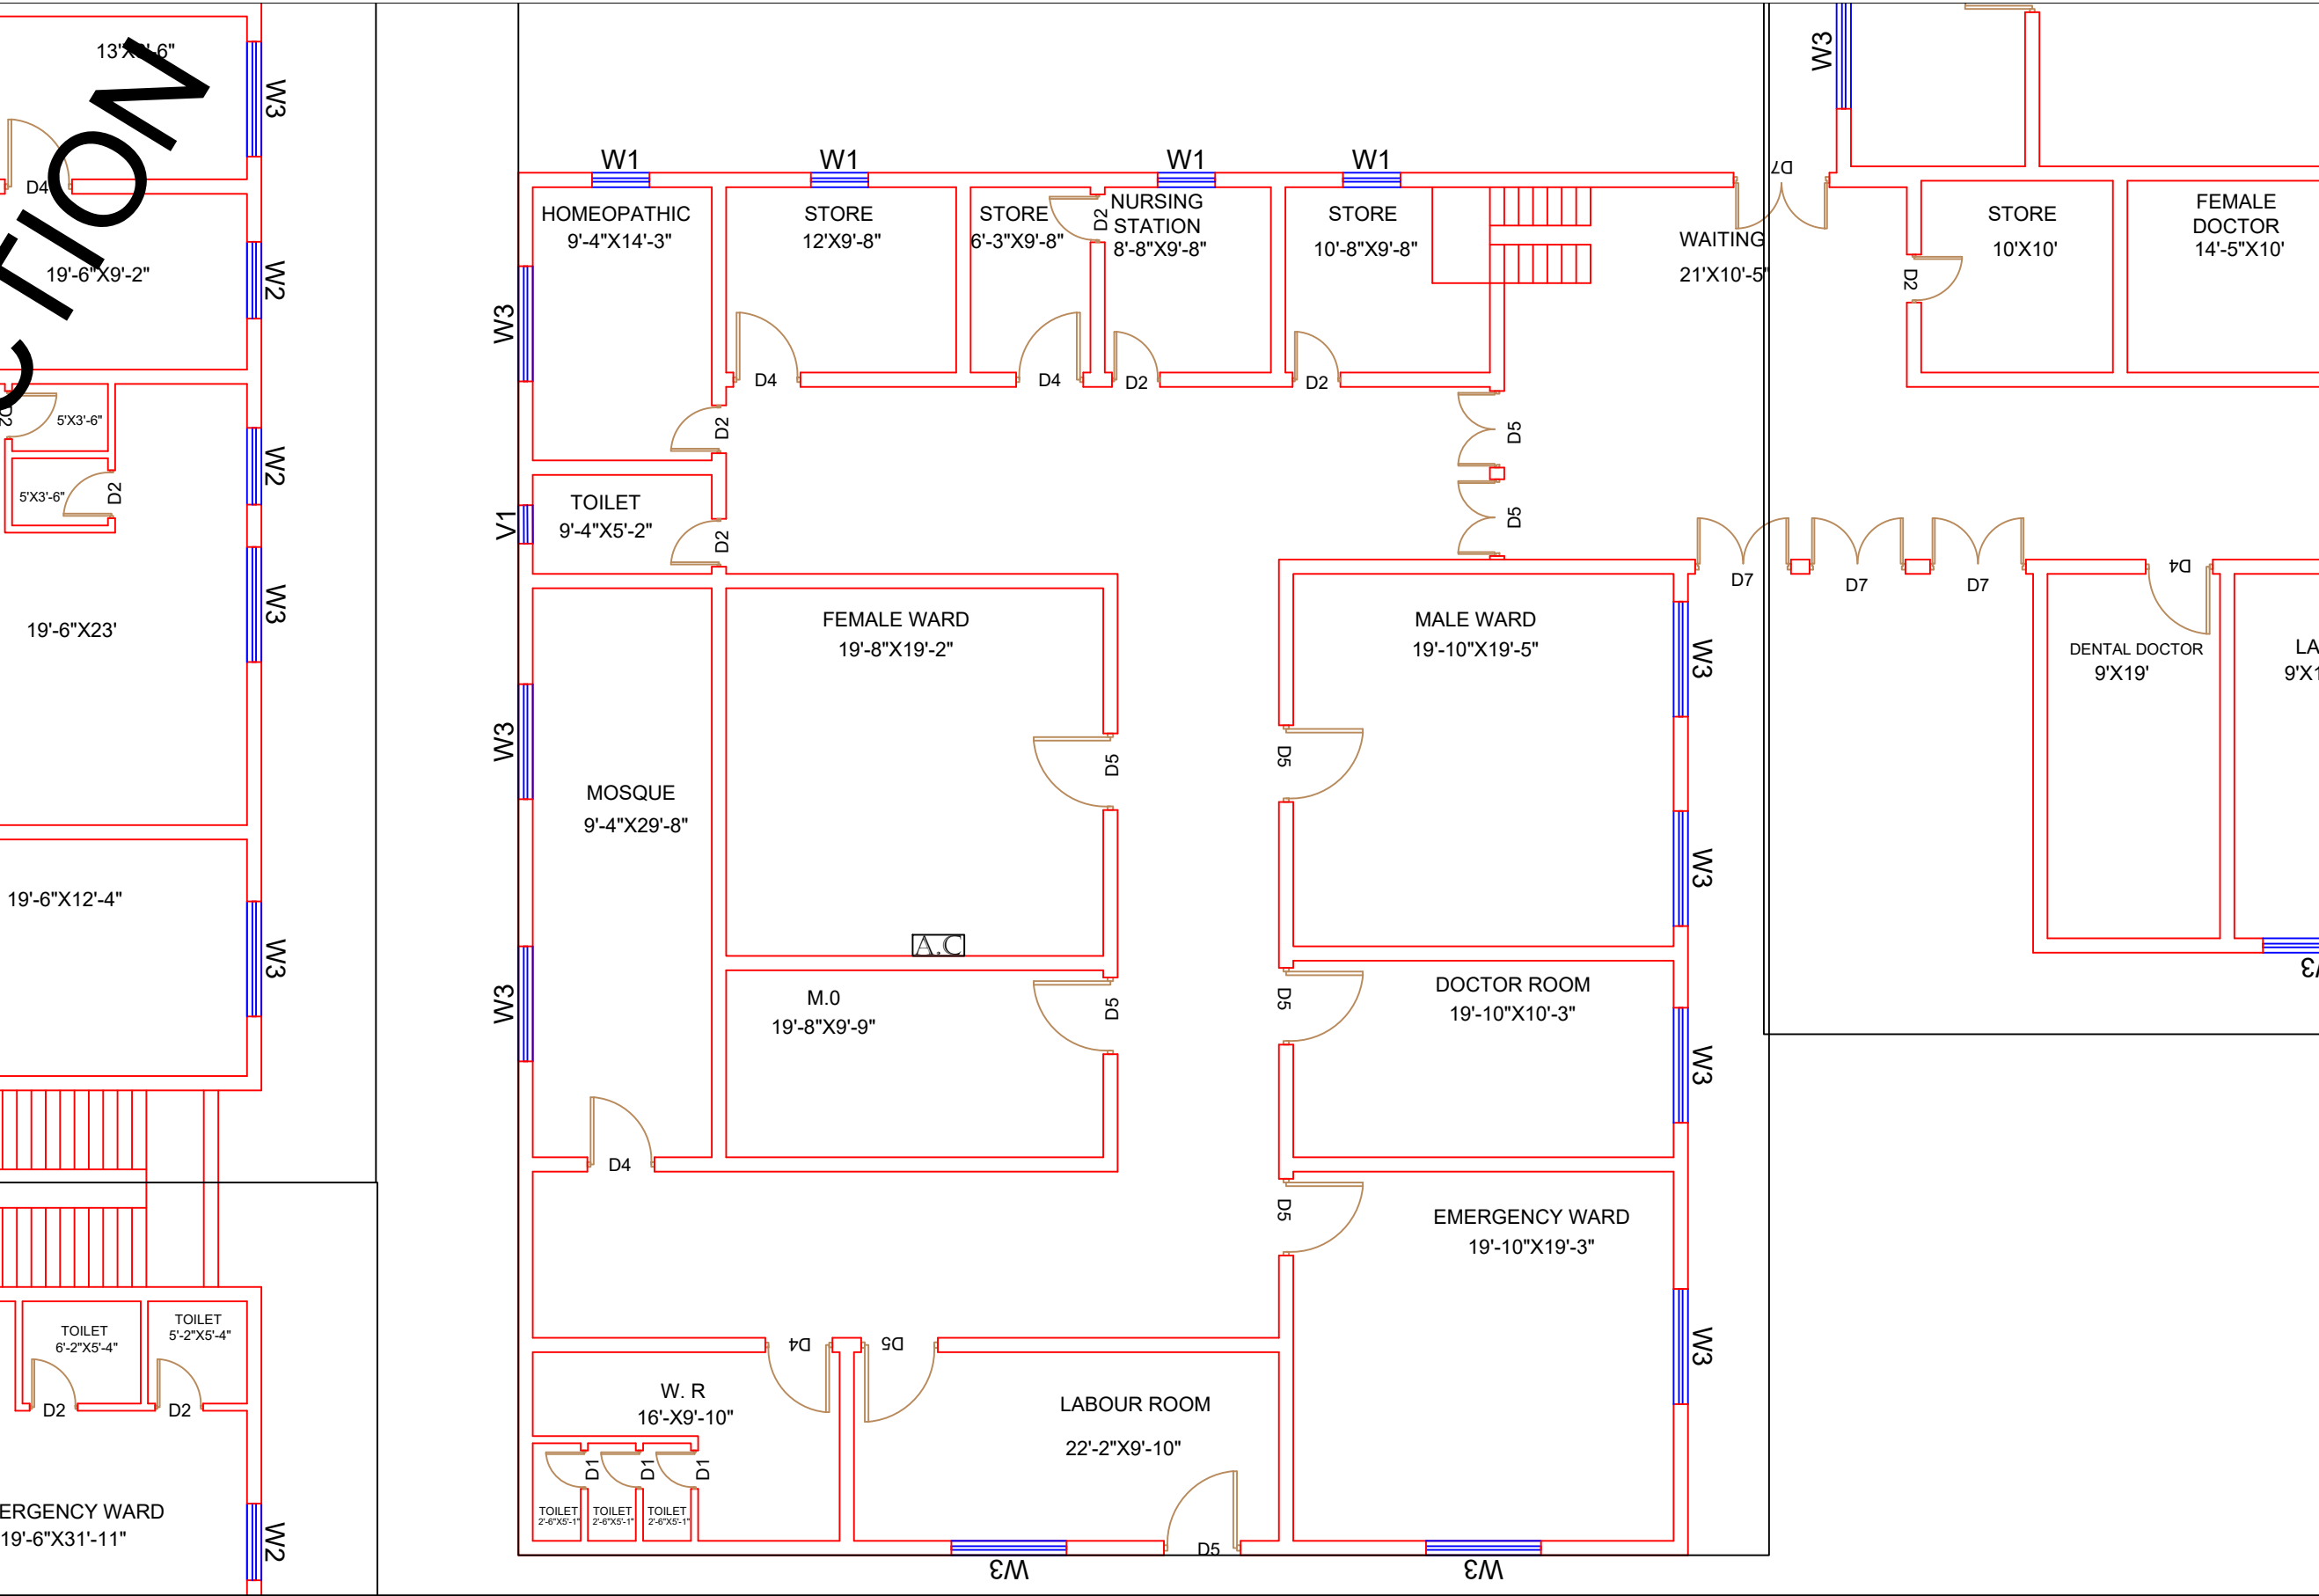

Legends:

Residential Area	
Road	
Wall	
Power Line	
OHT	
Tree	
Man Hole	
Tube Well	
Light Pole	
Lawns	
Earthen Areas	
Asphalts Roads	
Tough Pavers	
P.C.C / Plinth Protection	
Boundary Wall	
Brick Pavers / Soling	
Drain	
Tap	
Hand Pump	
Air Conditioner	
Tube Light	
Fan	
Roof Light	
Bulb	

AREA					
AREA WITHIN BOUNDARY WALL		79821.909 Sft			
AREA OF CLINICAL BLOCK		17200.118 Sft			
PLINTH AREA OF BLOCK		15247.951 Sft			

OPENING SCHEDULE OF DOORS AND WINDOWS					
DOORS	WIDTH	HEIGHT	WINDOWS	WIDTH	HEIGHT
D1	2'-0"	7'-0"	W1	3'-0"	5'-0"
D2	2'-6"	7'-0"	W2	4'-0"	4'-0"
D3	3'-0"	7'-0"	W3	6'-0"	6'-0"
D4	3'-6"	7'-0"	W4	8'-0"	8'-0"
D5	4'-0"	7'-0"	W5	5'-0"	5'-0"
D6	4'-6"	7'-0"	W6	8'-0"	8'-0"
D7	5'-0"	7'-0"	W7	2'-0"	2'-0"
D8	6'-0"	7'-0"	V1	2'-0"	2'-0"
D9	7'-0"	7'-0"	V2		

Project: **CAD MAPPING OF TEHSIL HEAD QUARTER HOSPITALS, PUNJAB**


Client:	Consultant:
GOVERNMENT OF THE PUNJAB PRIMARY & SECONDARY HEALTHCARE DEPARTMENT	SKAFS CONSULTANT (Pvt.) Limited ENGINEERING AND ENVIRONMENT CONSULTANT

Drawing Title: **THQ MURREE CLINICAL BLOCK PLAN (PART 3)**

Drawing No. **SKAFS/MURREE /11**

CLINICAL BLOCK OF THQ HOSPITAL MURREE

GROUND FLOOR PART 4

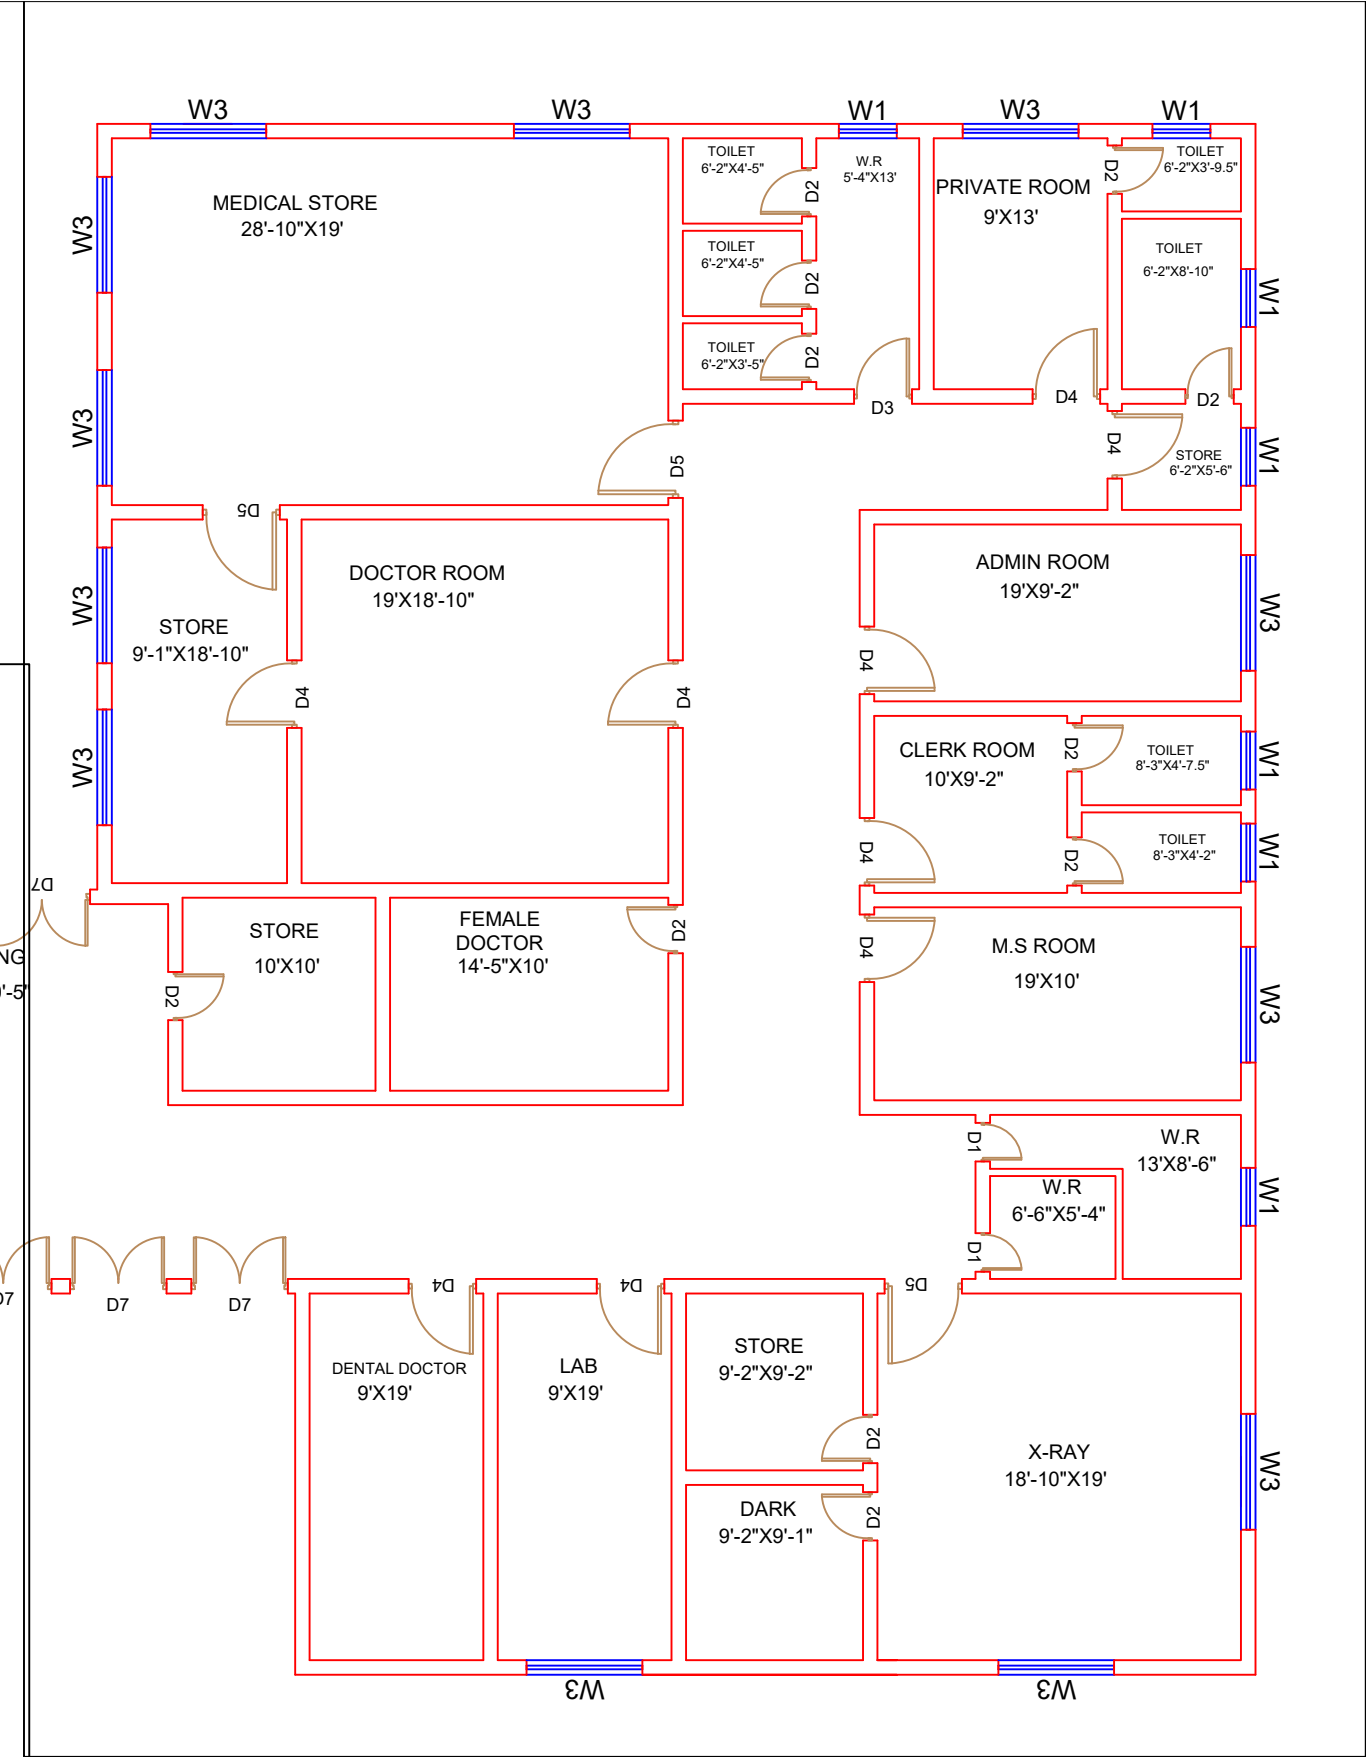

Legends:

Residential Area	
Road	
Wall	
Power Line	
OHT	
Tree	
Man Hole	
Tube Well	
Light Pole	
Lawns	
Earthen Areas	
Asphalts Roads	
Tough Pavers	
P.C.C / Plinth Protection	
Boundary Wall	
Brick Pavers / Soling	
Drain	
Tap	
Hand Pump	
Air Conditioner	
Tube Light	
Fan	
Roof Light	
Bulb	

AREA	
AREA WITHIN BOUNDARY WALL	79821.909 Sft
AREA OF CLINICAL BLOCK	17200.118 Sft
PLINTH AREA OF BLOCK	15247.951 Sft

OPENING SCHEDULE OF DOORS AND WINDOWS					
DOORS	WIDTH	HEIGHT	WINDOWS	WIDTH	HEIGHT
D1	2'-0"	7'-0"	W1	3'-0"	5'-0"
D2	2'-6"	7'-0"	W2	4'-0"	4'-0"
D3	3'-0"	7'-0"	W3	6'-0"	6'-0"
D4	3'-6"	7'-0"	W4	8'-0"	8'-0"
D5	4'-0"	7'-0"	W5	5'-0"	5'-0"
D6	4'-6"	7'-0"	W6	8'-0"	8'-0"
D7	5'-0"	7'-0"	W7	2'-0"	2'-0"
D8	6'-0"	7'-0"	V1	2'-0"	2'-0"
D9	7'-0"	7'-0"	V2		

Project:

CAD MAPPING OF TEHSIL HEAD QUARTER HOSPITALS, PUNJAB

Client:	Consultant:
 GOVERNMENT OF THE PUNJAB PRIMARY & SECONDARY HEALTHCARE DEPARTMENT	 SKAFS CONSULTANT (Pvt.) Limited ENGINEERING AND ENVIRONMENT CONSULTANT

Drawing Title: **THQ MURREE CLINICAL BLOCK PLAN (PART 4)**

Drawing No. **SKAFS/MURREE /12**

CLINICAL BLOCK OF THQ HOSPITAL MURREE

FIRST FLOOR PART 1

Legends:

Residential Area	
Road	
Wall	
Power Line	
OHT	
Tree	
Man Hole	
Tube Well	
Light Pole	
Lawns	
Earthen Areas	
Asphalts Roads	
Tough Pavers	
P.C.C / Plinth Protection	
Boundary Wall	
Brick Pavers / Soling	
Drain	
Tap	
Hand Pump	
Air Conditioner	
Tube Light	
Fan	
Roof Light	
Bulb	

AREA	
AREA WITHIN BOUNDARY WALL	79821.909 Sft
AREA OF CLINICAL BLOCK	17200.118 Sft
PLINTH AREA OF BLOCK	15247.951 Sft

OPENING SCHEDULE OF DOORS AND WINDOWS					
DOORS	WIDTH	HEIGHT	WINDOWS	WIDTH	HEIGHT
D1	2'-0"	7'-0"	W1	3'-0"	5'-0"
D2	2'-6"	7'-0"	W2	4'-0"	4'-0"
D3	3'-0"	7'-0"	W3	6'-0"	6'-0"
D4	3'-6"	7'-0"	W4	8'-0"	8'-0"
D5	4'-0"	7'-0"	W5	5'-0"	5'-0"
D6	4'-6"	7'-0"	W6	8'-0"	8'-0"
D7	5'-0"	7'-0"	W7	2'-0"	2'-0"
D8	6'-0"	7'-0"	V1	2'-0"	2'-0"
D9	7'-0"	7'-0"	V2		

Project:

CAD MAPPING OF TEHSIL
HEAD QUARTER HOSPITALS,
PUNJAB

Client:

GOVERNMENT OF THE PUNJAB
PRIMARY & SECONDARY
HEALTHCARE DEPARTMENT

Consultant:

SKAFS CONSULTANT (Pvt.)
Limited
ENGINEERING AND ENVIRONMENT
CONSULTANT

Drawing Title:

THQ MURREE
FIRST FLOOR PLAN (PART 1)


Drawing No.

SKAFS/MURREE /13

ELECTRICAL LAYOUT PLAN OF THQ HOSPITAL MURREE

GROUND FLOOR

Emergency

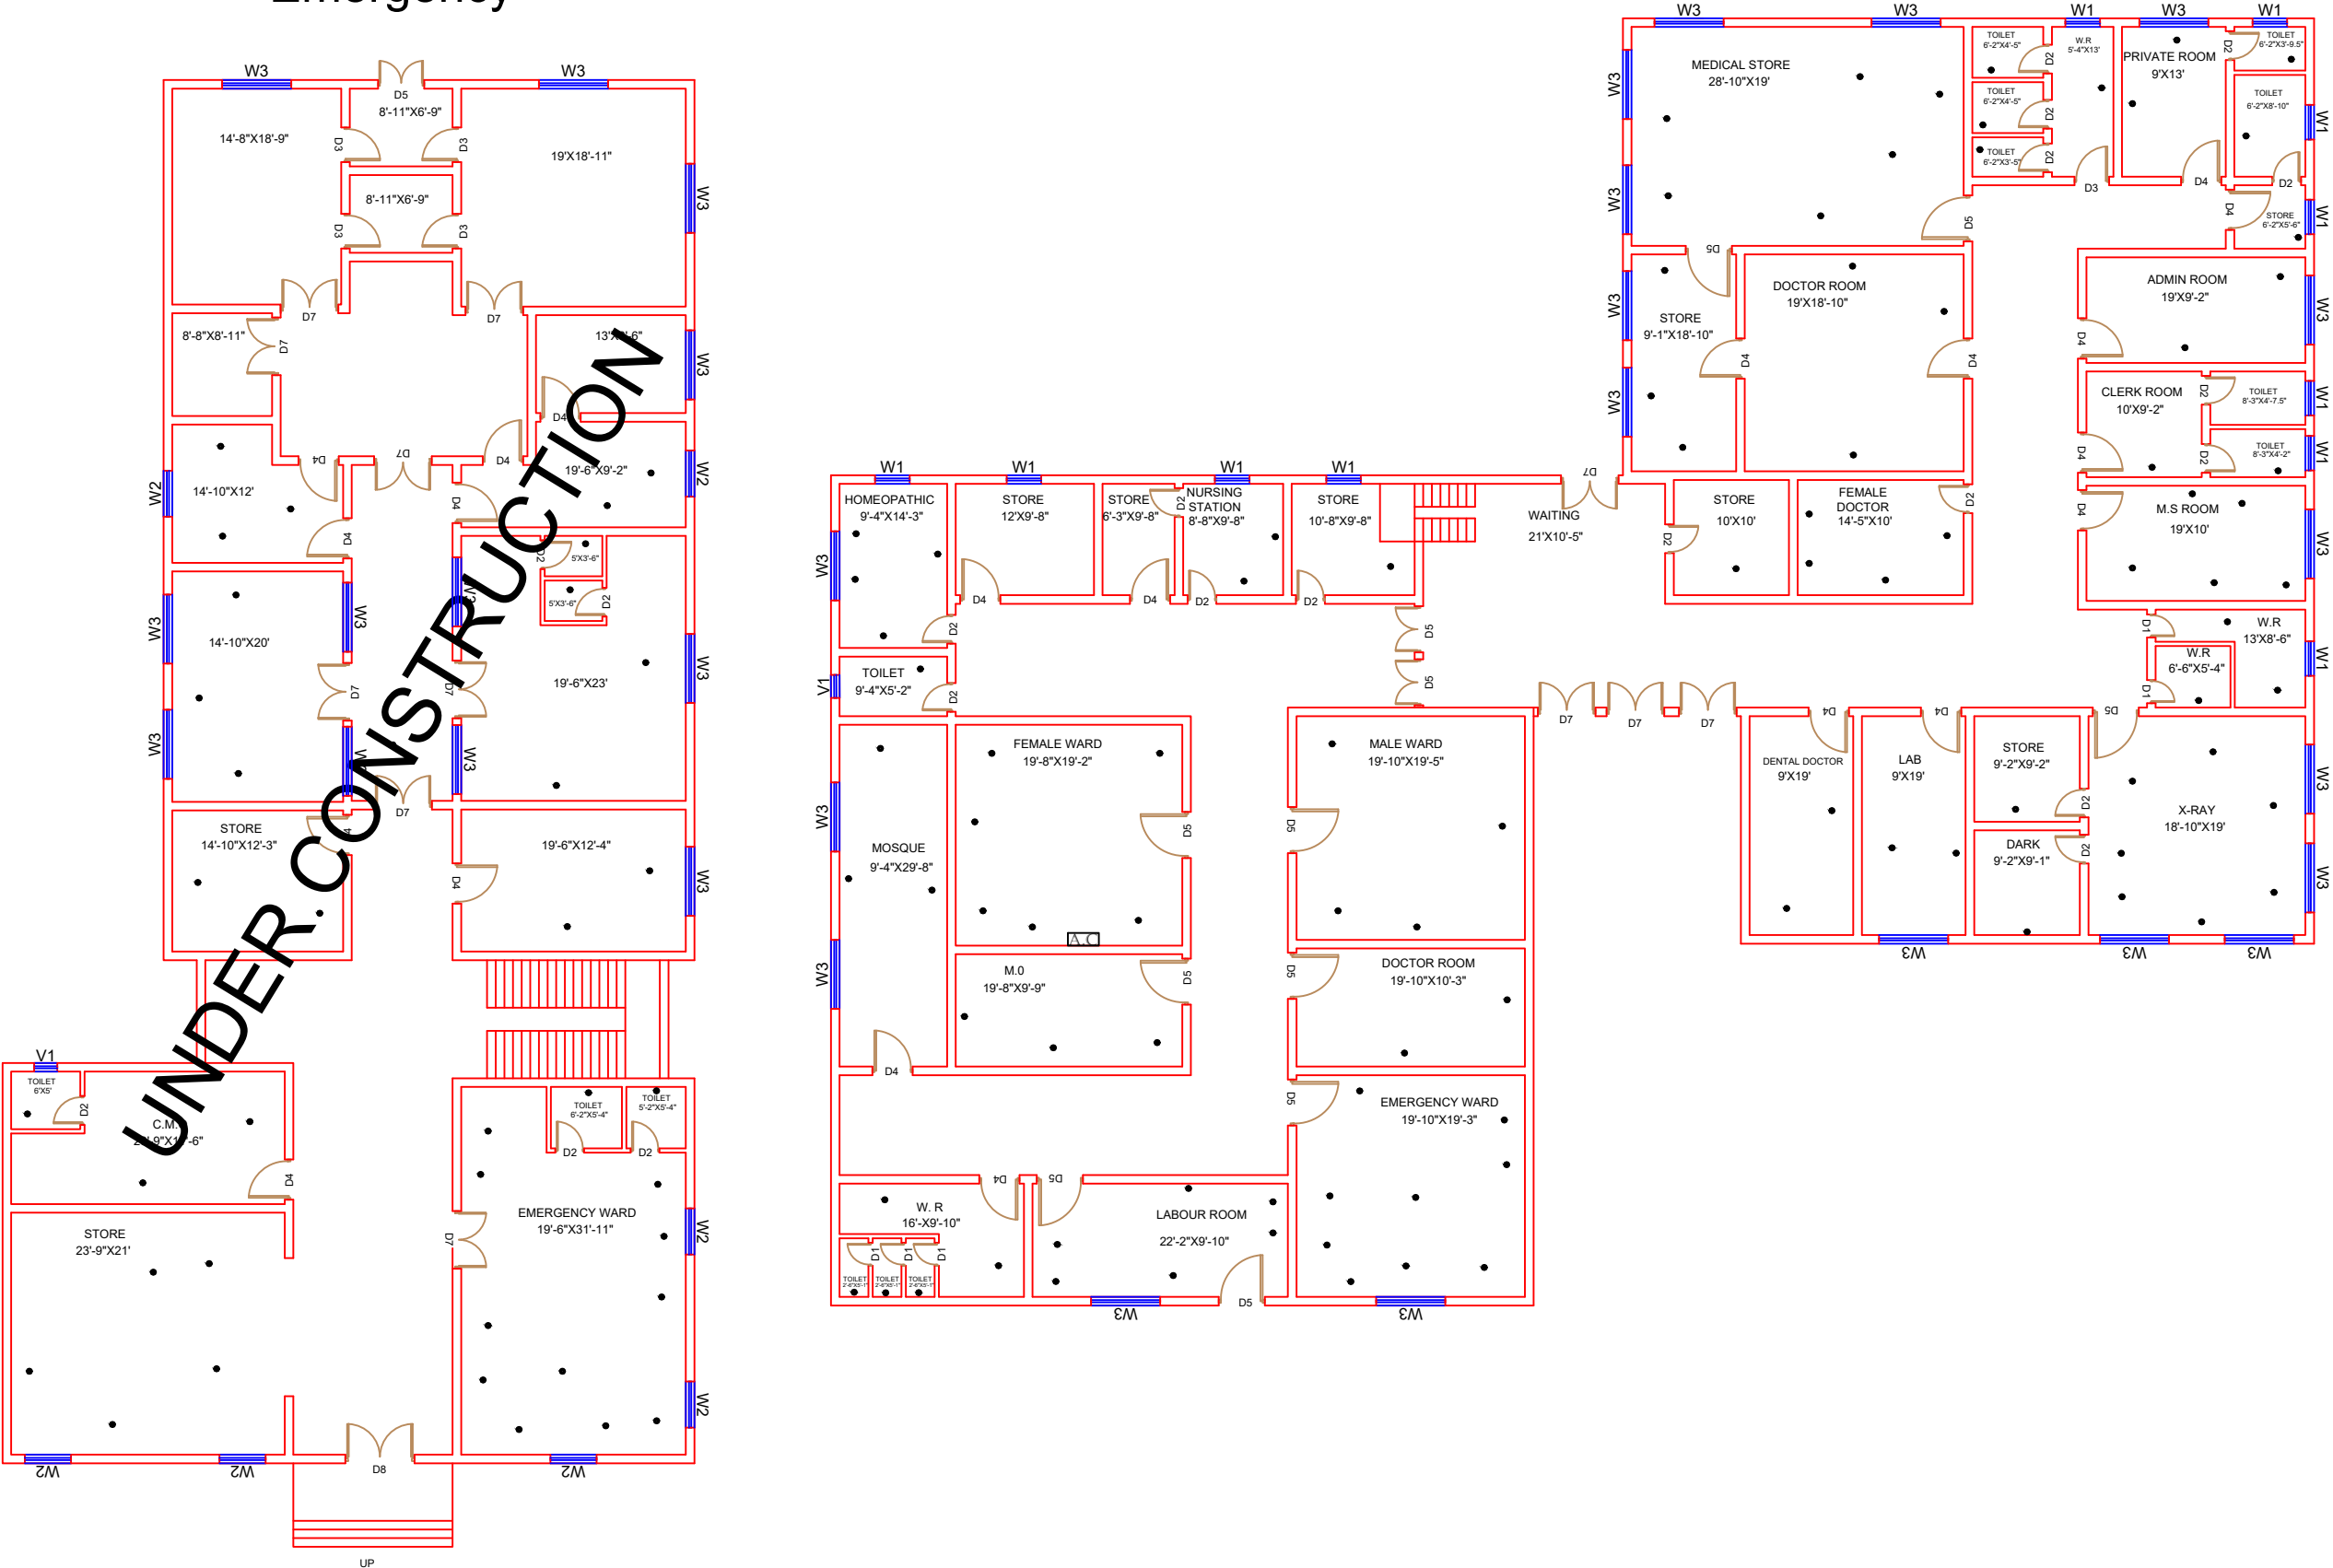

Project: **CAD MAPPING OF TEHSIL HEAD QUARTER HOSPITALS, PUNJAB**

Client: GOVERNMENT OF THE PUNJAB
PRIMARY & SECONDARY
HEALTHCARE DEPARTMENT


Consultant: SKAFS CONSULTANT (Pvt.)
Limited
ENGINEERING AND ENVIRONMENT
CONSULTANT

Drawing Title: **THQ MURREE
ELECTRICAL PLAN (GROUND FLOOR)**

Drawing No. **SKAFS/MURREE /14**

ELECTRICAL LAYOUT PLAN OF THQ HOSPITAL MURREE

FIRST FLOOR

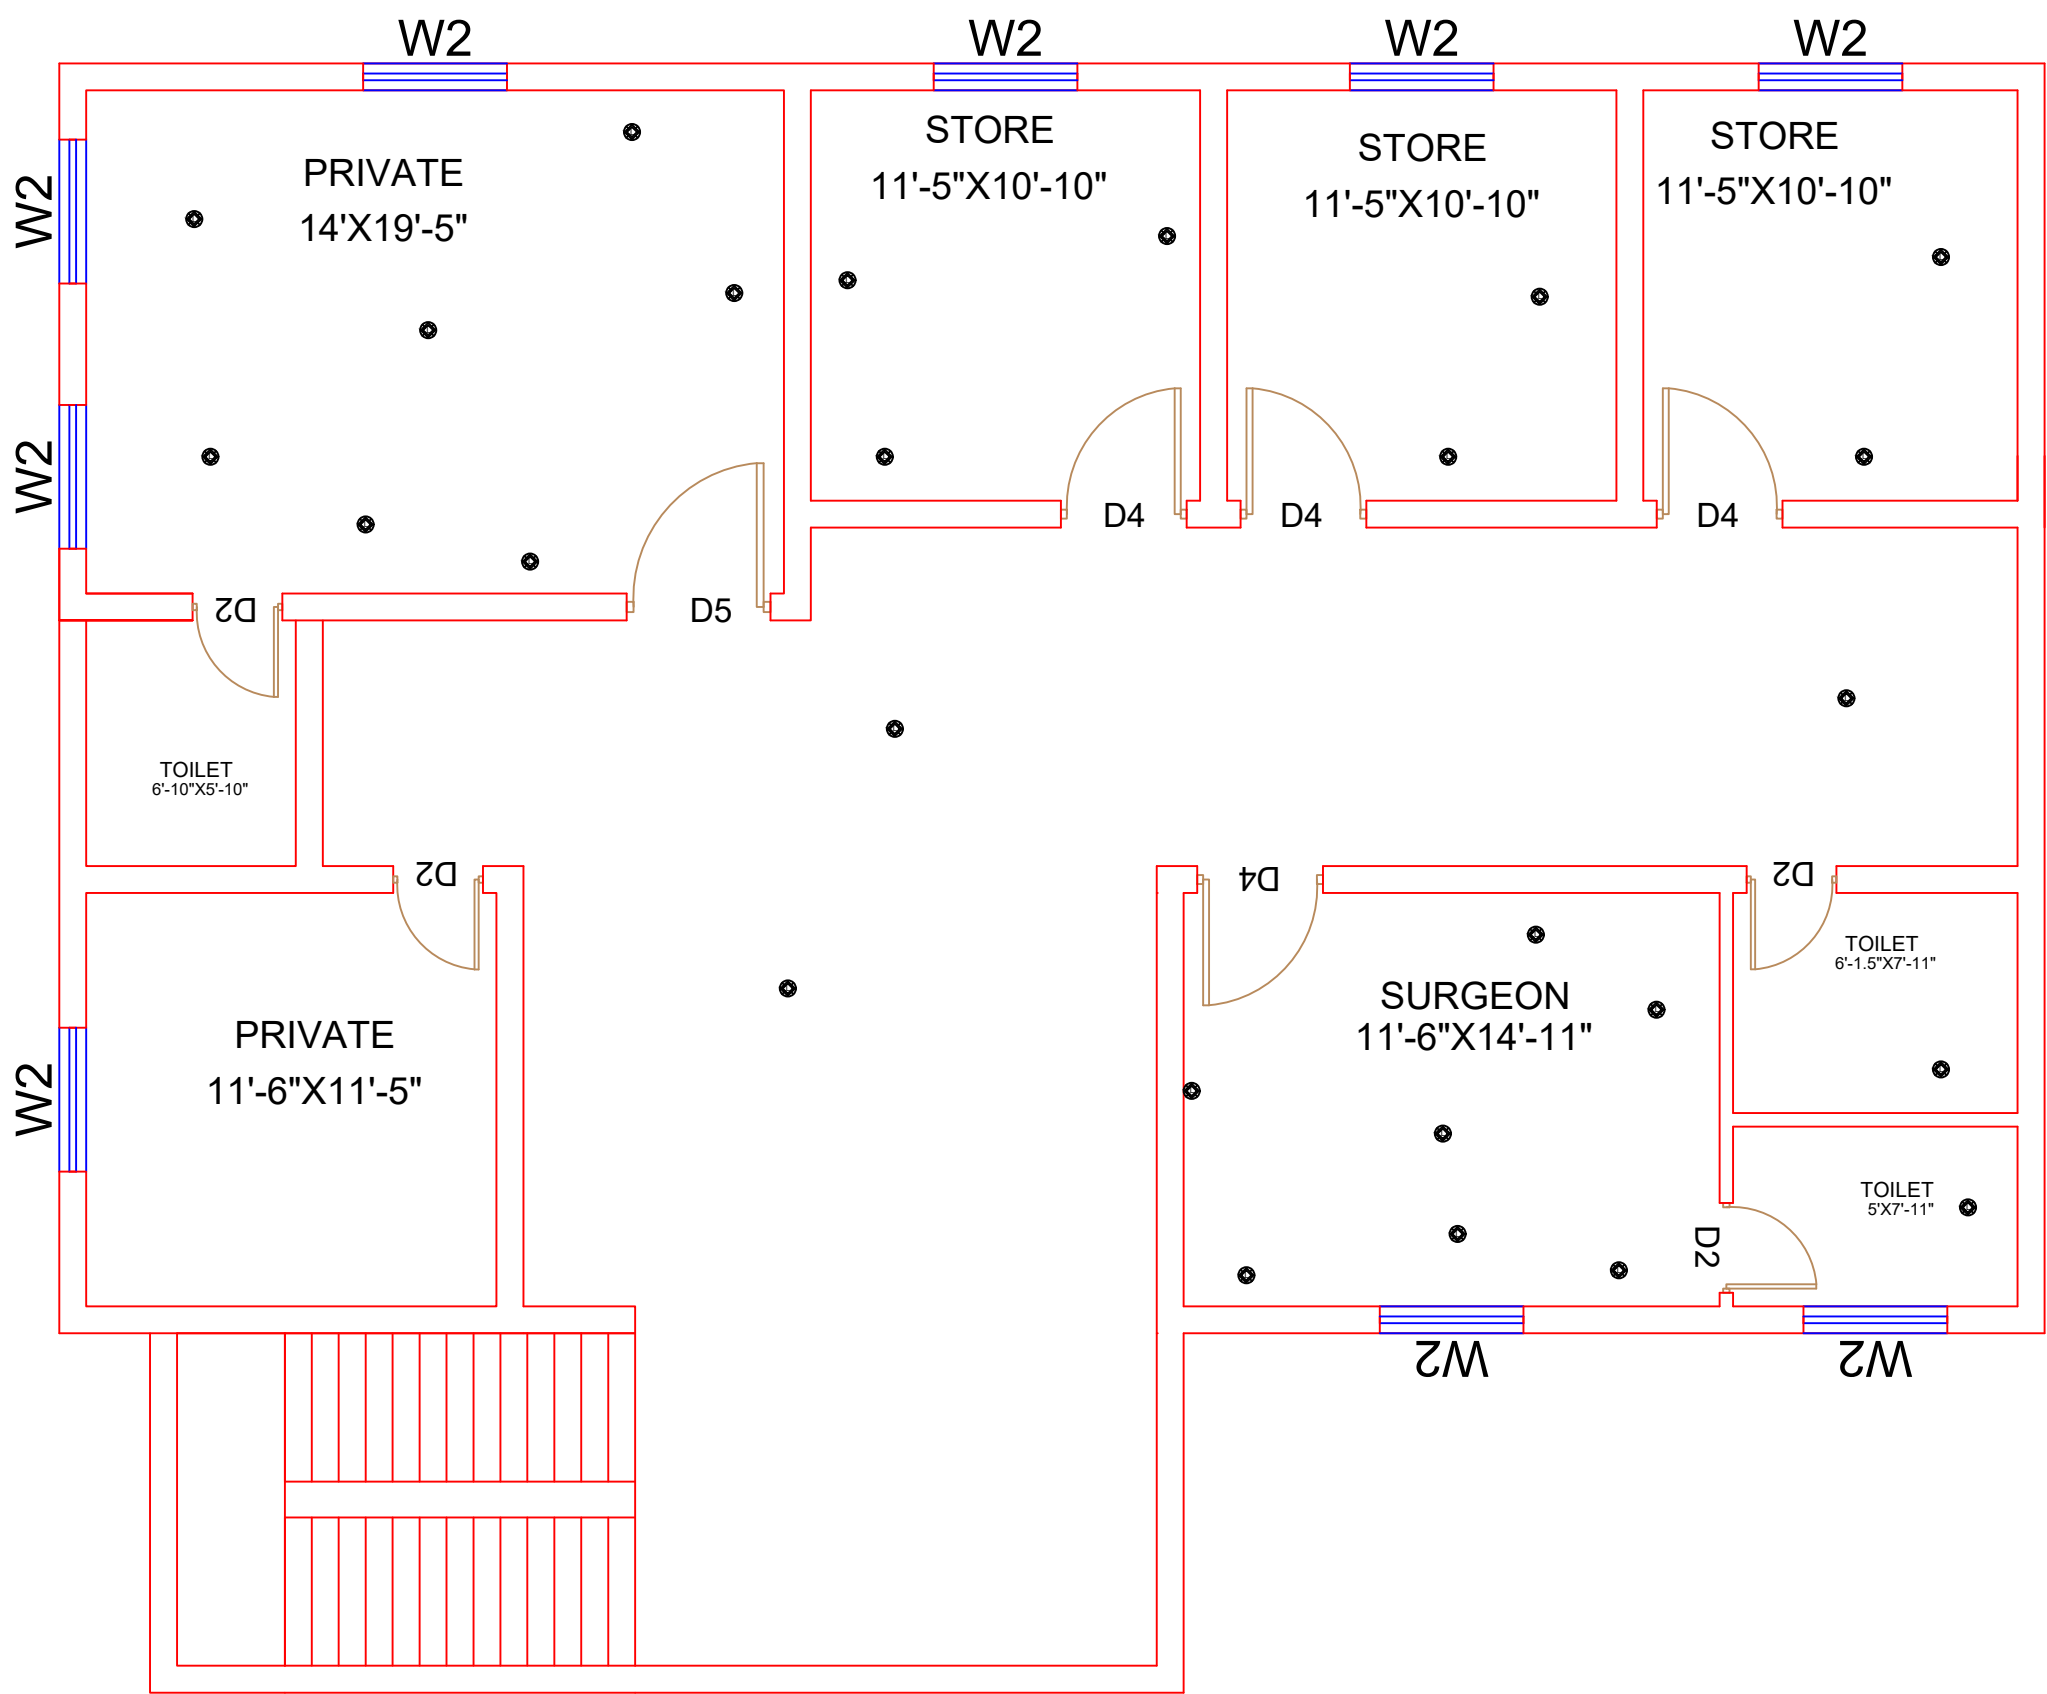

Legends:

Residential Area	
Road	
Wall	
Power Line	
OHT	
Tree	
Man Hole	
Tube Well	
Light Pole	
Lawns	
Earthen Areas	
Asphalts Roads	
Tough Pavers	
P.C.C / Plinth Protection	
Boundary Wall	
Brick Pavers / Soling	
Drain	
Tap	
Hand Pump	
Air Conditioner	
Tube Light	
Fan	
Roof Light	
Bulb	

AREA	
AREA WITHIN BOUNDARY WALL	79821.909 Sft
AREA OF CLINICAL BLOCK	17200.118 Sft
PLINTH AREA OF BLOCK	15247.951 Sft

OPENING SCHEDULE OF DOORS AND WINDOWS					
DOORS	WIDTH	HEIGHT	WINDOWS	WIDTH	HEIGHT
D1	2'-0"	7'-0"	W1	3'-0"	5'-0"
D2	2'-6"	7'-0"	W2	4'-0"	4'-0"
D3	3'-0"	7'-0"	W3	6'-0"	6'-0"
D4	3'-6"	7'-0"	W4	8'-0"	8'-0"
D5	4'-0"	7'-0"	W5	5'-0"	5'-0"
D6	4'-6"	7'-0"	W6	8'-0"	8'-0"
D7	5'-0"	7'-0"	W7	2'-0"	2'-0"
D8	6'-0"	7'-0"	V1	2'-0"	2'-0"
D9	7'-0"	7'-0"	V2		

Project:
**CAD MAPPING OF TEHSIL
HEAD QUARTER HOSPITALS,
PUNJAB**

Client: GOVERNMENT OF THE PUNJAB PRIMARY & SECONDARY HEALTHCARE DEPARTMENT	Consultant: SKAFS CONSULTANT (Pvt.) Limited ENGINEERING AND ENVIRONMENT CONSULTANT
---	--

Drawing Title: **THQ MURREE
ELECTRICAL PLAN (FIRST FLOOR)**

Drawing No. **SKAFS/MURREE /15**