




MASTER PLAN OF THQ HOSPITAL TALAGANG

PART 1

PART 2

PART 3

PART 4

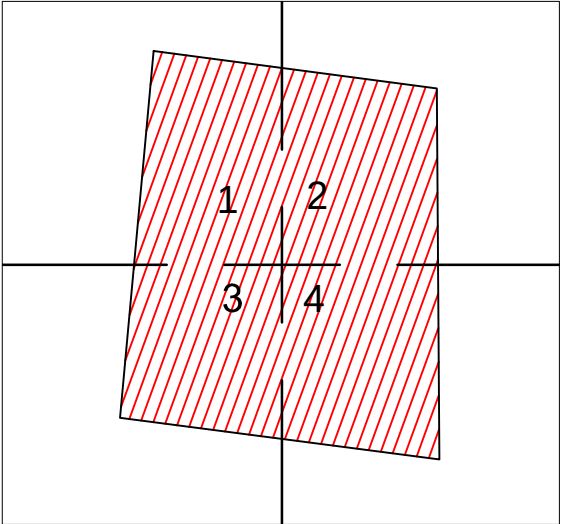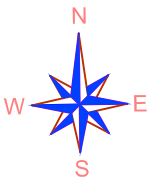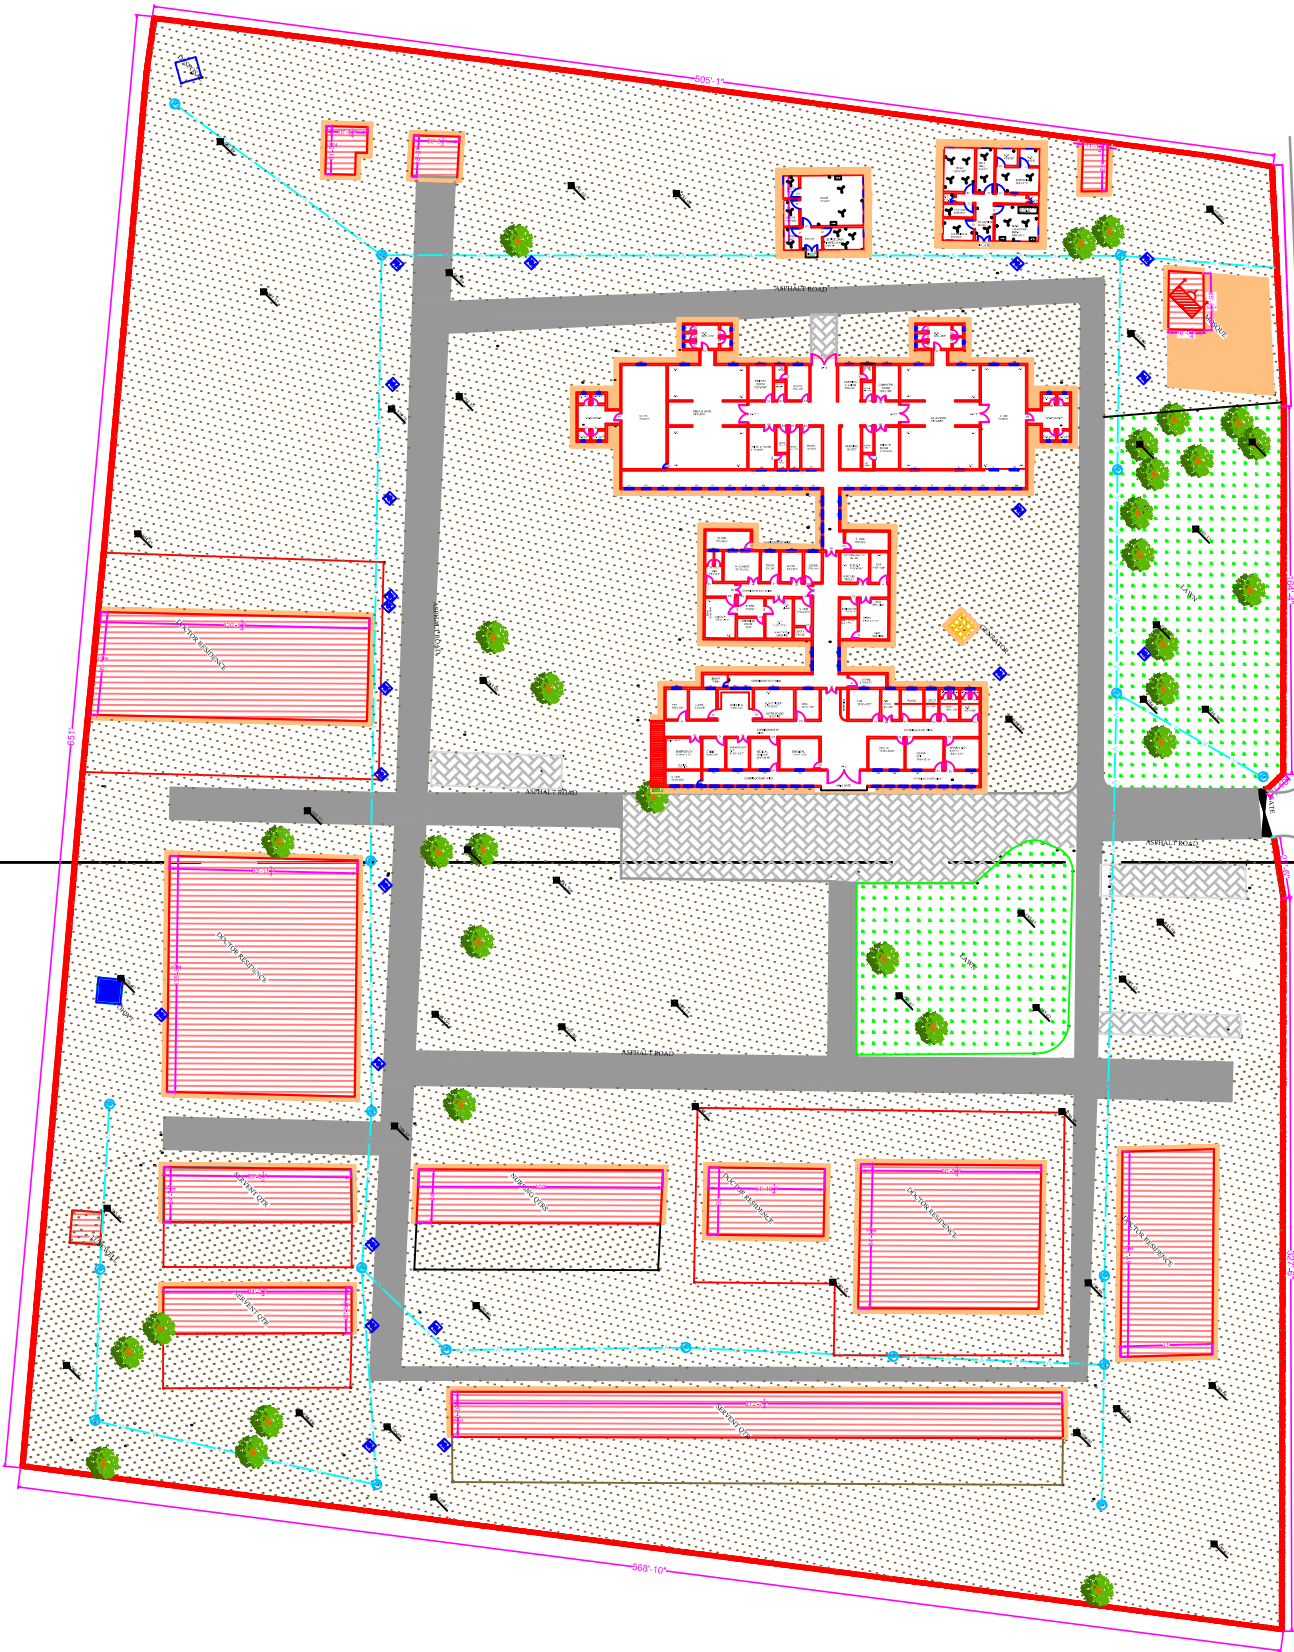

Legends:



Residential Area	
Road	
Wall	
Power Line	
OHT	
Tree	
Man Hole	
Tube Well	
Light Pole	
Lawns	
Earthen Areas	
Asphalts Roads	
Tough Pavers	
P.C.C / Plinth Protection	
Boundary Wall	
Brick Pavers / Soling	
Drain	
Tap	
Hand Pump	
Air Conditioner	
Tube Light	
Fan	
Roof Light	
Bulb	

AREA					
AREA WITHIN BOUNDARY WALL			351195.14 Sft		
AREA OF CLINICAL BLOCK			21276.028 Sft		
PLINTH AREA OF BLOCK			21276.028 Sft		
OPENING SCHEDULE OF DOORS AND WINDOWS					
DOORS	WIDTH	HEIGHT	WINDOWS	WIDTH	HEIGHT
D1	5'-6"	7'-0"	W1	3'-0"	3'-0"
D2	5'-0"	7'-0"	W2	3'-6"	3'-6"
D3	4'-0"	7'-0"	W3	6'-0"	6'-0"
D4	3'-6"	7'-0"	W4	4'-6"	4'-6"
D5	3'-0"	7'-0"	W5	8'-6"	8'-6"
D6	2'-6"	7'-0"	W6	2'-6"	2'-6"
D7	6'-0"	7'-0"	W7	4'-0"	4'-0"
V1	1'-6"	1'-6"	V1	5'-0"	5'-0"
V2	2'-0"	2'-0"	V2	7'-0"	7'-0"

Project:	
CAD MAPPING OF TEHSIL HEAD QUARTER HOSPITALS, PUNJAB	
Client:	Consultant:
 GOVERNMENT OF THE PUNJAB PRIMARY & SECONDARY HEALTHCARE DEPARTMENT	 SKAFS CONSULTANT (Pvt.) Limited ENGINEERING AND ENVIRONMENT CONSULTANT
Drawing Title:	
THQ TALAGANG HOSPITAL MASTER PLAN	
Drawing No.	
SKAFS/TALAGANG /03	

MASTER PLAN OF THQ HOSPITAL TALAGANG

PART 1

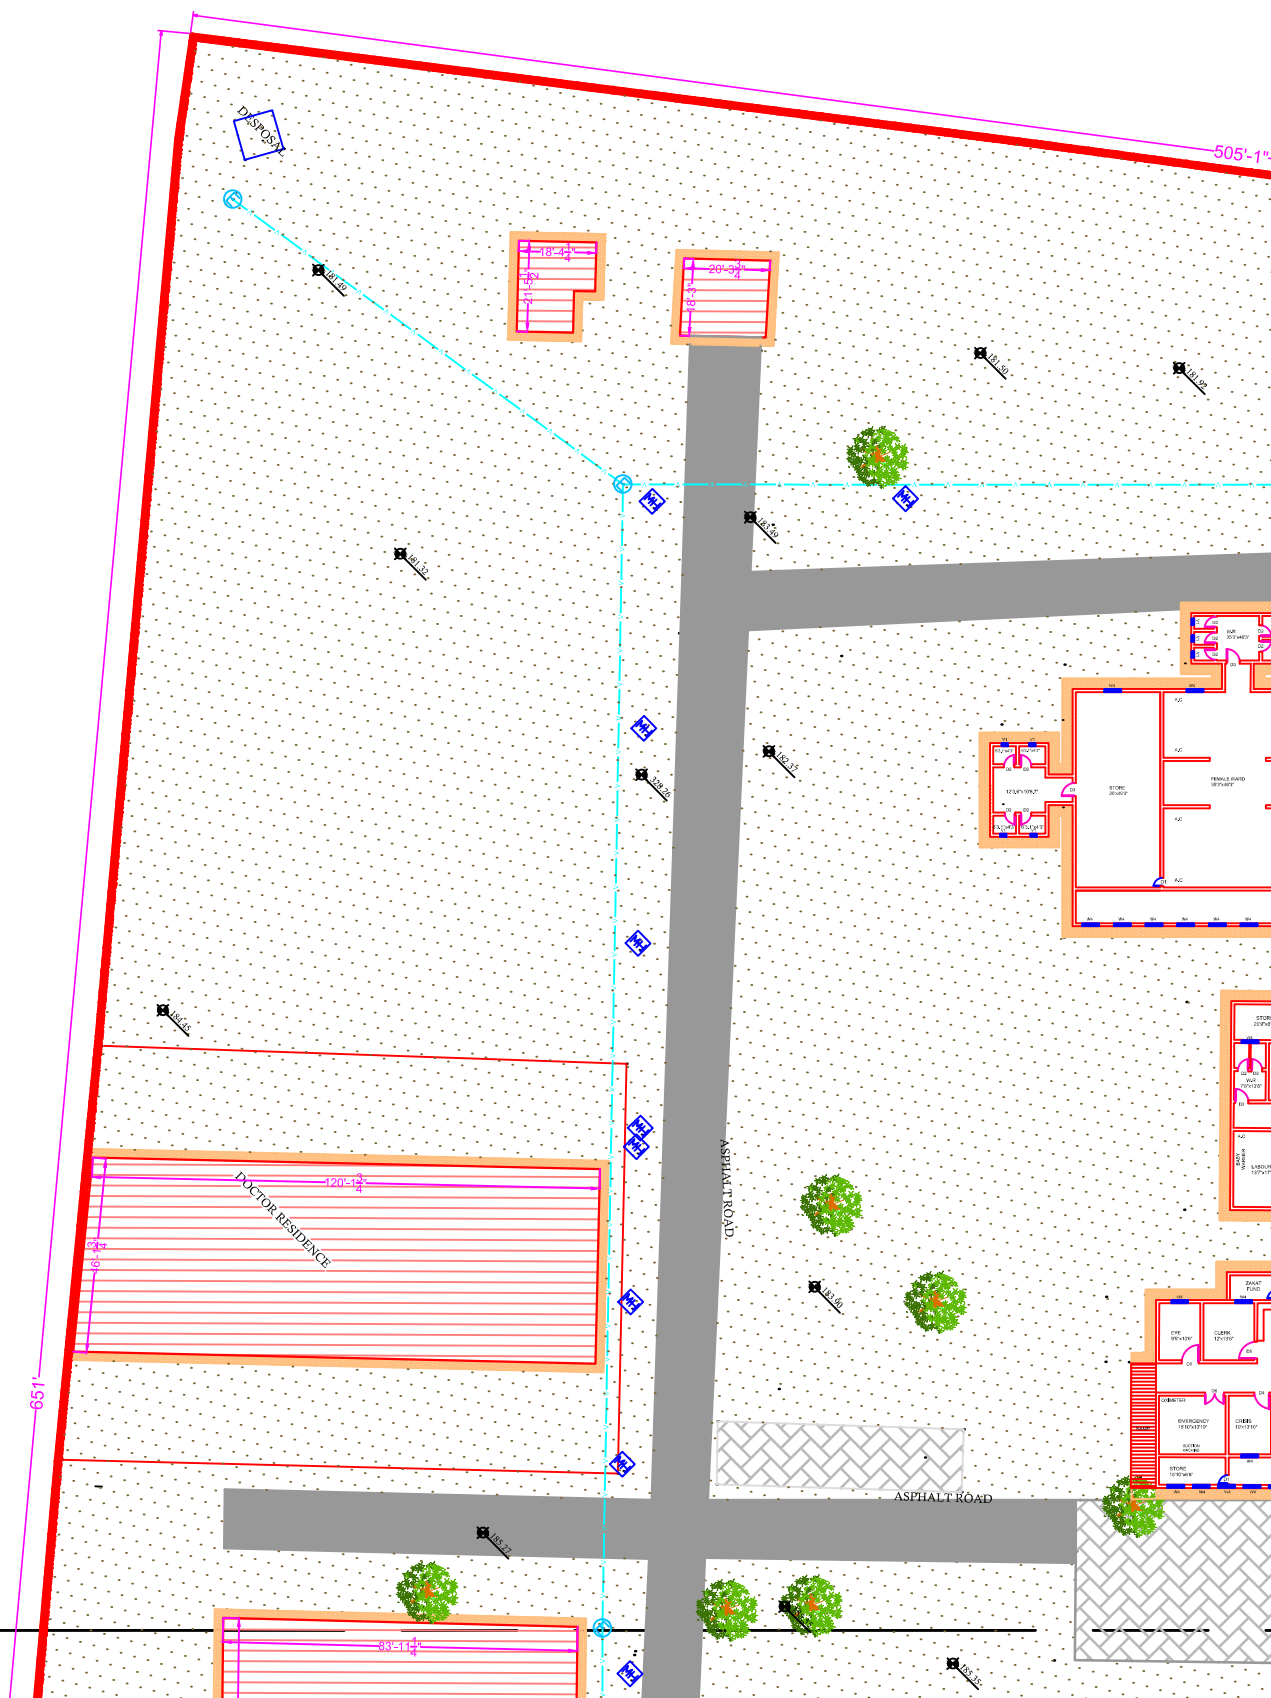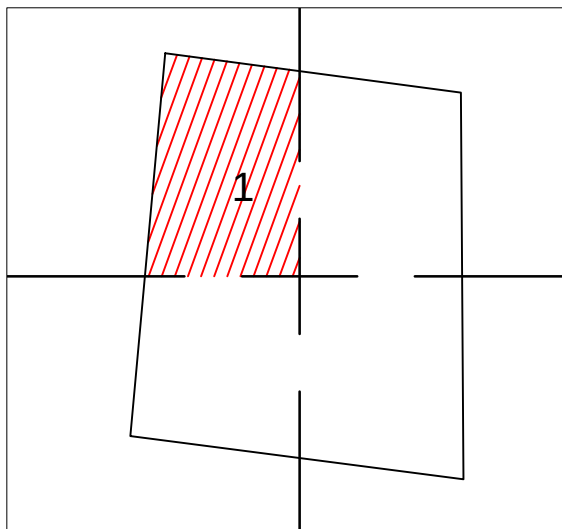

Legends:	
Residential Area	
Road	
Wall	
Power Line	
OHT	
Tree	
Man Hole	
Tube Well	
Light Pole	
Lawns	
Earthen Areas	
Asphalts Roads	
Tough Pavers	
P.C.C / Plinth Protection	
Boundary Wall	
Brick Pavers / Soling	
Drain	
Tap	
Hand Pump	
Air Conditioner	
Tube Light	
Fan	
Roof Light	
Bulb	

AREA	
AREA WITHIN BOUNDARY WALL	351195.14 Sft
AREA OF CLINICAL BLOCK	21276.028 Sft
PLINTH AREA OF BLOCK	21276.028 Sft

OPENING SCHEDULE OF DOORS AND WINDOWS					
DOORS	WIDTH	HEIGHT	WINDOWS	WIDTH	HEIGHT
D1	5'-6"	7'-0"	W1	3'-0"	3'-0"
D2	5'-0"	7'-0"	W2	3'-6"	3'-6"
D3	4'-0"	7'-0"	W3	6'-0"	6'-0"
D4	3'-6"	7'-0"	W4	4'-6"	4'-6"
D5	3'-0"	7'-0"	W5	8'-6"	8'-6"
D6	2'-6"	7'-0"	W6	2'-6"	2'-6"
D7	6'-0"	7'-0"	W7	4'-0"	4'-0"
V1	1'-6"	1'-6"	V1	5'-0"	5'-0"
V2	2'-0"	2'-0"	V2	7'-0"	7'-0"

Project:
**CAD MAPPING OF TEHSIL
HEAD QUARTER HOSPITALS,
PUNJAB**

Client:

GOVERNMENT OF THE PUNJAB
PRIMARY & SECONDARY
HEALTHCARE DEPARTMENT

Consultant:


SKAFS CONSULTANT (Pvt.)
Limited
ENGINEERING AND ENVIRONMENT
CONSULTANT

Drawing Title:
**THQ TALAGANG
HOSPITAL MASTER PLAN PART 1**

Drawing No.
SKAFS/TALAGANG /04

MASTER PLAN OF THQ HOSPITAL TALAGANG

PART 2

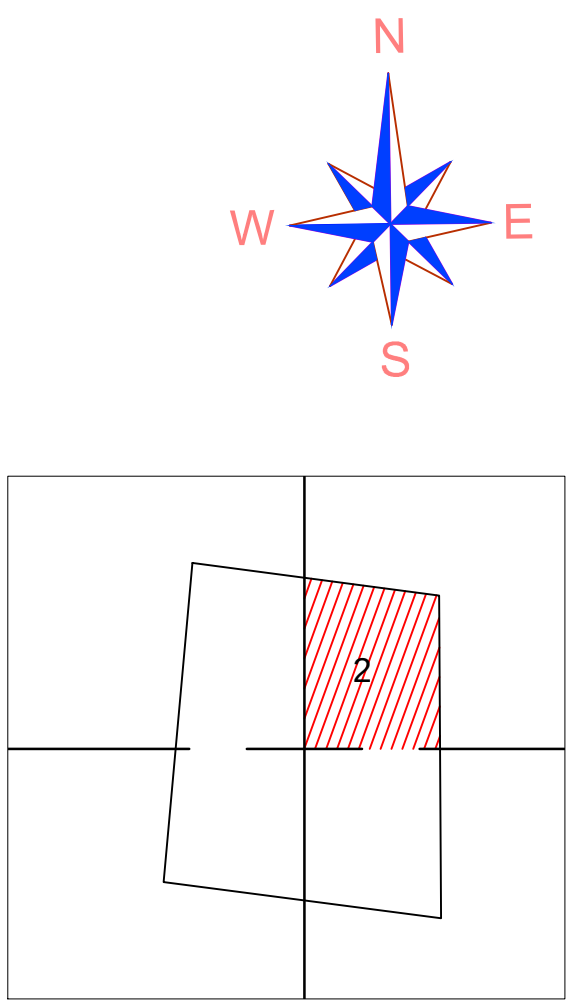

Legends:

Residential Area	
Road	
Wall	
Power Line	
OHT	
Tree	
Man Hole	
Tube Well	
Light Pole	
Lawns	
Earthen Areas	
Asphalts Roads	
Tough Pavers	
P.C.C / Plinth Protection	
Boundary Wall	
Brick Pavers / Soling	
Drain	
Tap	
Hand Pump	
Air Conditioner	
Tube Light	
Fan	
Roof Light	
Bulb	

AREA					
AREA WITHIN BOUNDARY WALL			351195.14 Sft		
AREA OF CLINICAL BLOCK			21276.028 Sft		
PLINTH AREA OF BLOCK			21276.028 Sft		
OPENING SCHEDULE OF DOORS AND WINDOWS					
DOORS	WIDTH	HEIGHT	WINDOWS	WIDTH	HEIGHT
D1	5'-6"	7'-0"	W1	3'-0"	3'-0"
D2	5'-0"	7'-0"	W2	3'-6"	3'-6"
D3	4'-0"	7'-0"	W3	6'-0"	6'-0"
D4	3'-6"	7'-0"	W4	4'-6"	4'-6"
D5	3'-0"	7'-0"	W5	8'-6"	8'-6"
D6	2'-6"	7'-0"	W6	2'-6"	2'-6"
D7	6'-0"	7'-0"	W7	4'-0"	4'-0"
V1	1'-6"	1'-6"	V1	5'-0"	5'-0"
V2	2'-0"	2'-0"	V2	7'-0"	7'-0"

Project:

CAD MAPPING OF TEHSIL
HEAD QUARTER HOSPITALS,
PUNJAB

Client:



GOVERNMENT OF THE PUNJAB
PRIMARY & SECONDARY
HEALTHCARE DEPARTMENT

Consultant:



SKAFS CONSULTANT (Pvt.)
Limited
ENGINEERING AND ENVIRONMENT
CONSULTANT

Drawing Title:


THQ TALAGANG
HOSPITAL MASTER PLAN PART 2

Drawing No.

SKAFS/TALAGANG /05

MASTER PLAN OF THQ HOSPITAL TALAGANG

PART 3

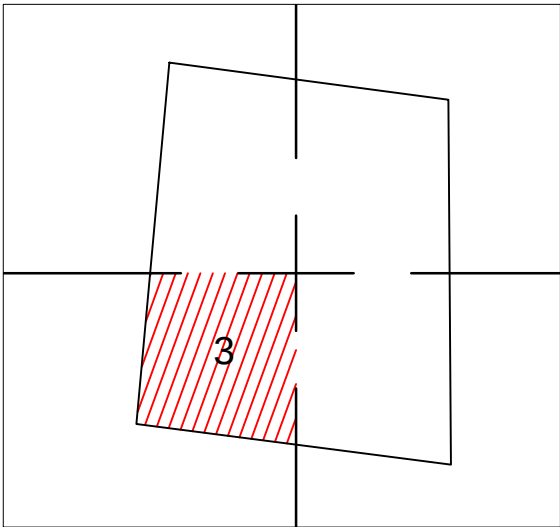

Legends:

Residential Area	
Road	
Wall	
Power Line	
OHT	
Tree	
Man Hole	
Tube Well	
Light Pole	
Lawns	
Earthen Areas	
Asphalts Roads	
Tough Pavers	
P.C.C / Plinth Protection	
Boundary Wall	
Brick Pavers / Soling	
Drain	
Tap	
Hand Pump	
Air Conditioner	
Tube Light	
Fan	
Roof Light	
Bulb	

AREA					
AREA WITHIN BOUNDARY WALL		351195.14 Sft			
AREA OF CLINICAL BLOCK		21276.028 Sft			
PLINTH AREA OF BLOCK		21276.028 Sft			

OPENING SCHEDULE OF DOORS AND WINDOWS					
DOORS	WIDTH	HEIGHT	WINDOWS	WIDTH	HEIGHT
D1	5'-6"	7'-0"	W1	3'-0"	3'-0"
D2	5'-0"	7'-0"	W2	3'-6"	3'-6"
D3	4'-0"	7'-0"	W3	6'-0"	6'-0"
D4	3'-6"	7'-0"	W4	4'-6"	4'-6"
D5	3'-0"	7'-0"	W5	8'-6"	8'-6"
D6	2'-6"	7'-0"	W6	2'-6"	2'-6"
D7	6'-0"	7'-0"	W7	4'-0"	4'-0"
V1	1'-6"	1'-6"	V1	5'-0"	5'-0"
V2	2'-0"	2'-0"	V2	7'-0"	7'-0"

Project:

CAD MAPPING OF TEHSIL HEAD QUARTER HOSPITALS, PUNJAB


Client:	Consultant:
 GOVERNMENT OF THE PUNJAB PRIMARY & SECONDARY HEALTHCARE DEPARTMENT	 SKAFS CONSULTANT (Pvt.) Limited ENGINEERING AND ENVIRONMENT CONSULTANT

Drawing Title: **THQ TALAGANG HOSPITAL MASTER PLAN PART 3**

Drawing No. **SKAFS/TALAGANG /06**

MASTER PLAN OF THQ HOSPITAL TALAGANG

PART 4

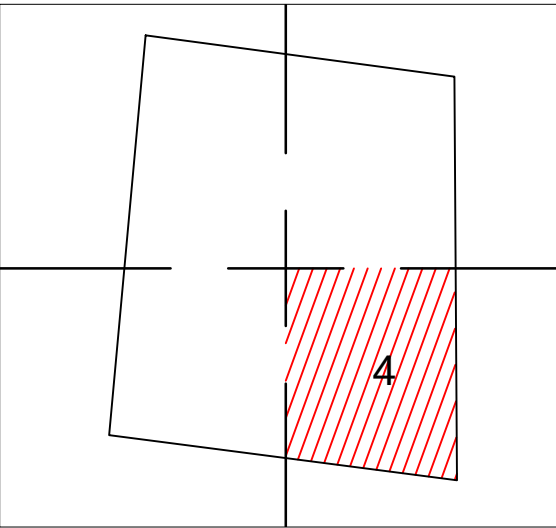

Legends:

Residential Area	
Road	
Wall	
Power Line	
OHT	
Tree	
Man Hole	
Tube Well	
Light Pole	
Lawns	
Earthen Areas	
Asphalts Roads	
Tough Pavers	
P.C.C / Plinth Protection	
Boundary Wall	
Brick Pavers / Soling	
Drain	
Tap	
Hand Pump	
Air Conditioner	
Tube Light	
Fan	
Roof Light	
Bulb	

AREA	
AREA WITHIN BOUNDARY WALL	351195.14 Sft
AREA OF CLINICAL BLOCK	21276.028 Sft
PLINTH AREA OF BLOCK	21276.028 Sft

OPENING SCHEDULE OF DOORS AND WINDOWS					
DOORS	WIDTH	HEIGHT	WINDOWS	WIDTH	HEIGHT
D1	5'-6"	7'-0"	W1	3'-0"	3'-0"
D2	5'-0"	7'-0"	W2	3'-6"	3'-6"
D3	4'-0"	7'-0"	W3	6'-0"	6'-0"
D4	3'-6"	7'-0"	W4	4'-6"	4'-6"
D5	3'-0"	7'-0"	W5	8'-6"	8'-6"
D6	2'-6"	7'-0"	W6	2'-6"	2'-6"
D7	6'-0"	7'-0"	W7	4'-0"	4'-0"
V1	1'-6"	1'-6"	V1	5'-0"	5'-0"
V2	2'-0"	2'-0"	V2	7'-0"	7'-0"

Project:

CAD MAPPING OF TEHSIL HEAD QUARTER HOSPITALS, PUNJAB

Client:	Consultant:
 GOVERNMENT OF THE PUNJAB PRIMARY & SECONDARY HEALTHCARE DEPARTMENT	 SKAFS CONSULTANT (Pvt.) Limited ENGINEERING AND ENVIRONMENT CONSULTANT

Drawing Title: **THQ TALAGANG HOSPITAL MASTER PLAN PART 4**


Drawing No. **SKAFS/TALAGANG /07**

CLINICAL BLOCK OF THQ HOSPITAL TALAGANG

GROUND FLOOR


PART 1

PART 2

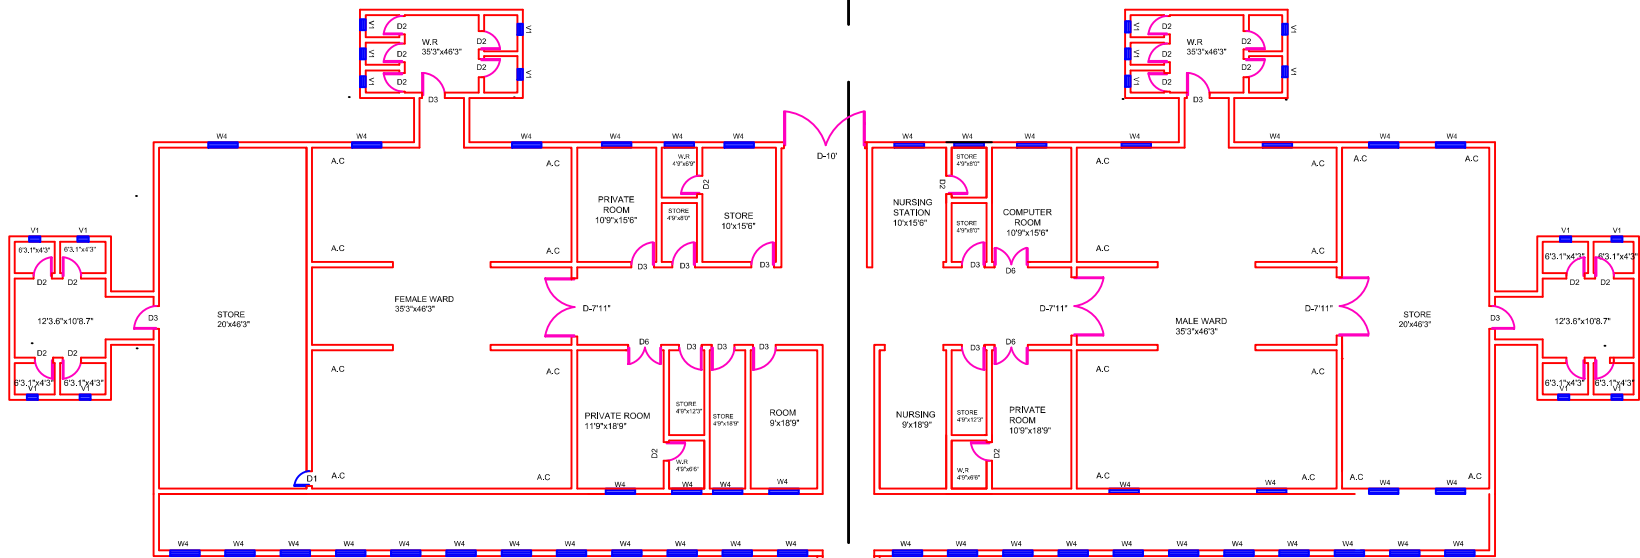

PART 3

PART 4

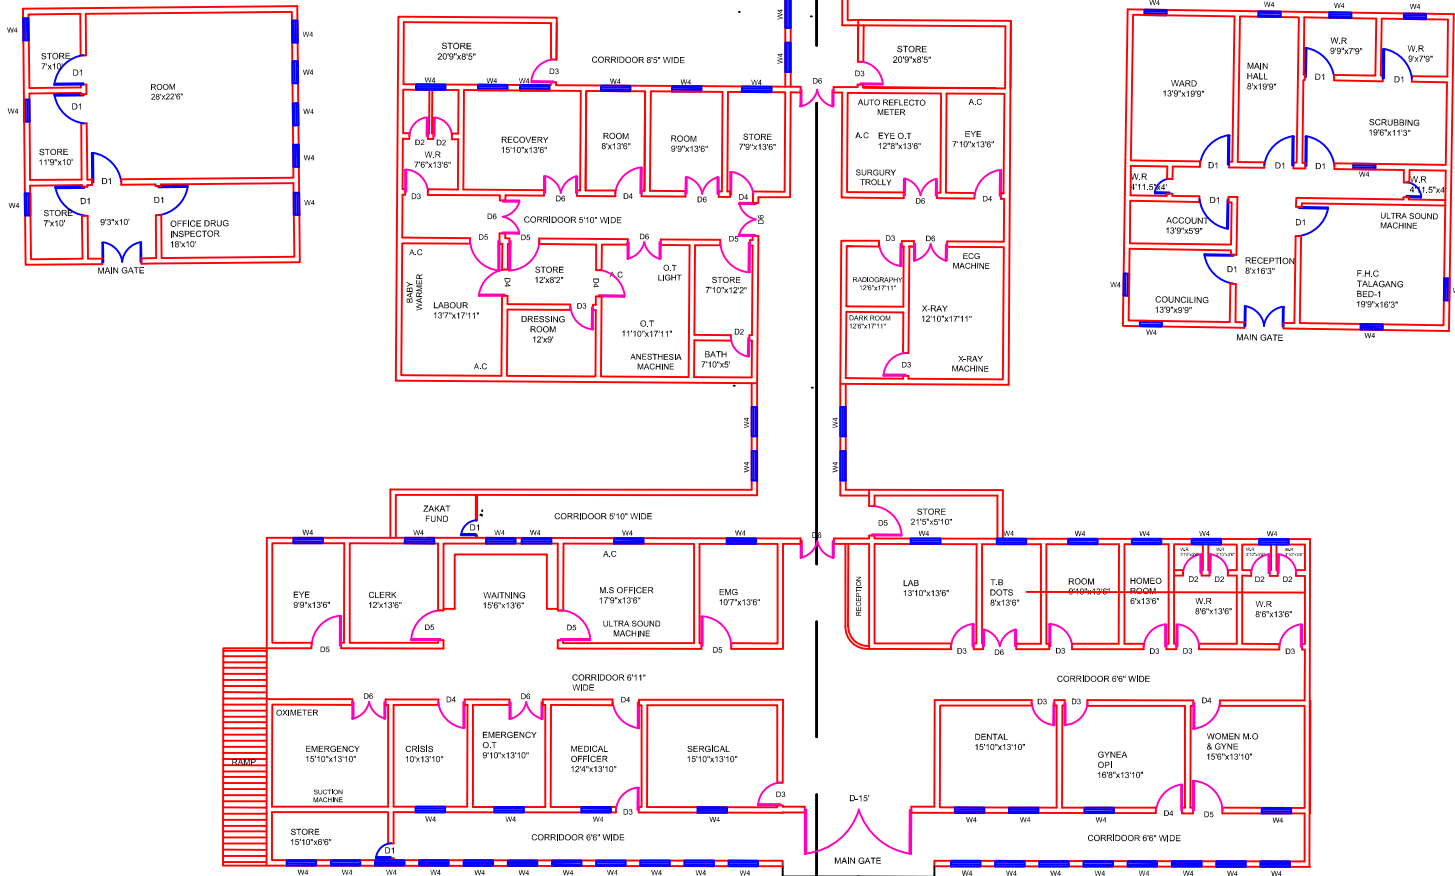

Legends:

Residential Area	
Road	
Wall	
Power Line	
OHT	
Tree	
Man Hole	
Tube Well	
Light Pole	
Lawns	
Earthen Areas	
Asphalts Roads	
Tough Pavers	
P.C.C / Plinth Protection	
Boundary Wall	
Brick Pavers / Soling	
Drain	
Tap	
Hand Pump	
Air Conditioner	
Tube Light	
Fan	
Roof Light	
Bulb	

AREA	
AREA WITHIN BOUNDARY WALL	351195.14 Sft
AREA OF CLINICAL BLOCK	21276.028 Sft
PLINTH AREA OF BLOCK	21276.028 Sft

OPENING SCHEDULE OF DOORS AND WINDOWS					
DOORS	WIDTH	HEIGHT	WINDOWS	WIDTH	HEIGHT
D1	5'-6"	7'-0"	W1	3'-0"	3'-0"
D2	5'-0"	7'-0"	W2	3'-6"	3'-6"
D3	4'-0"	7'-0"	W3	6'-0"	6'-0"
D4	3'-6"	7'-0"	W4	4'-6"	4'-6"
D5	3'-0"	7'-0"	W5	8'-6"	8'-6"
D6	2'-6"	7'-0"	W6	2'-6"	2'-6"
D7	6'-0"	7'-0"	W7	4'-0"	4'-0"
V1	1'-6"	1'-6"	V1	5'-0"	5'-0"
V2	2'-0"	2'-0"	V2	7'-0"	7'-0"

Project:
**CAD MAPPING OF TEHSIL
HEAD QUARTER HOSPITALS,
PUNJAB**


Client:	Consultant:
 GOVERNMENT OF THE PUNJAB PRIMARY & SECONDARY HEALTHCARE DEPARTMENT	 SKAFS CONSULTANT (Pvt.) Limited ENGINEERING AND ENVIRONMENT CONSULTANT

Drawing Title: **THQ TALAGANG
HOSPITAL CLINICAL BLOCK PLAN**

Drawing No. **SKAFS/TALAGANG /08**

CLINICAL BLOCK OF THQ HOSPITAL TALAGANG

GROUND FLOOR PART 1

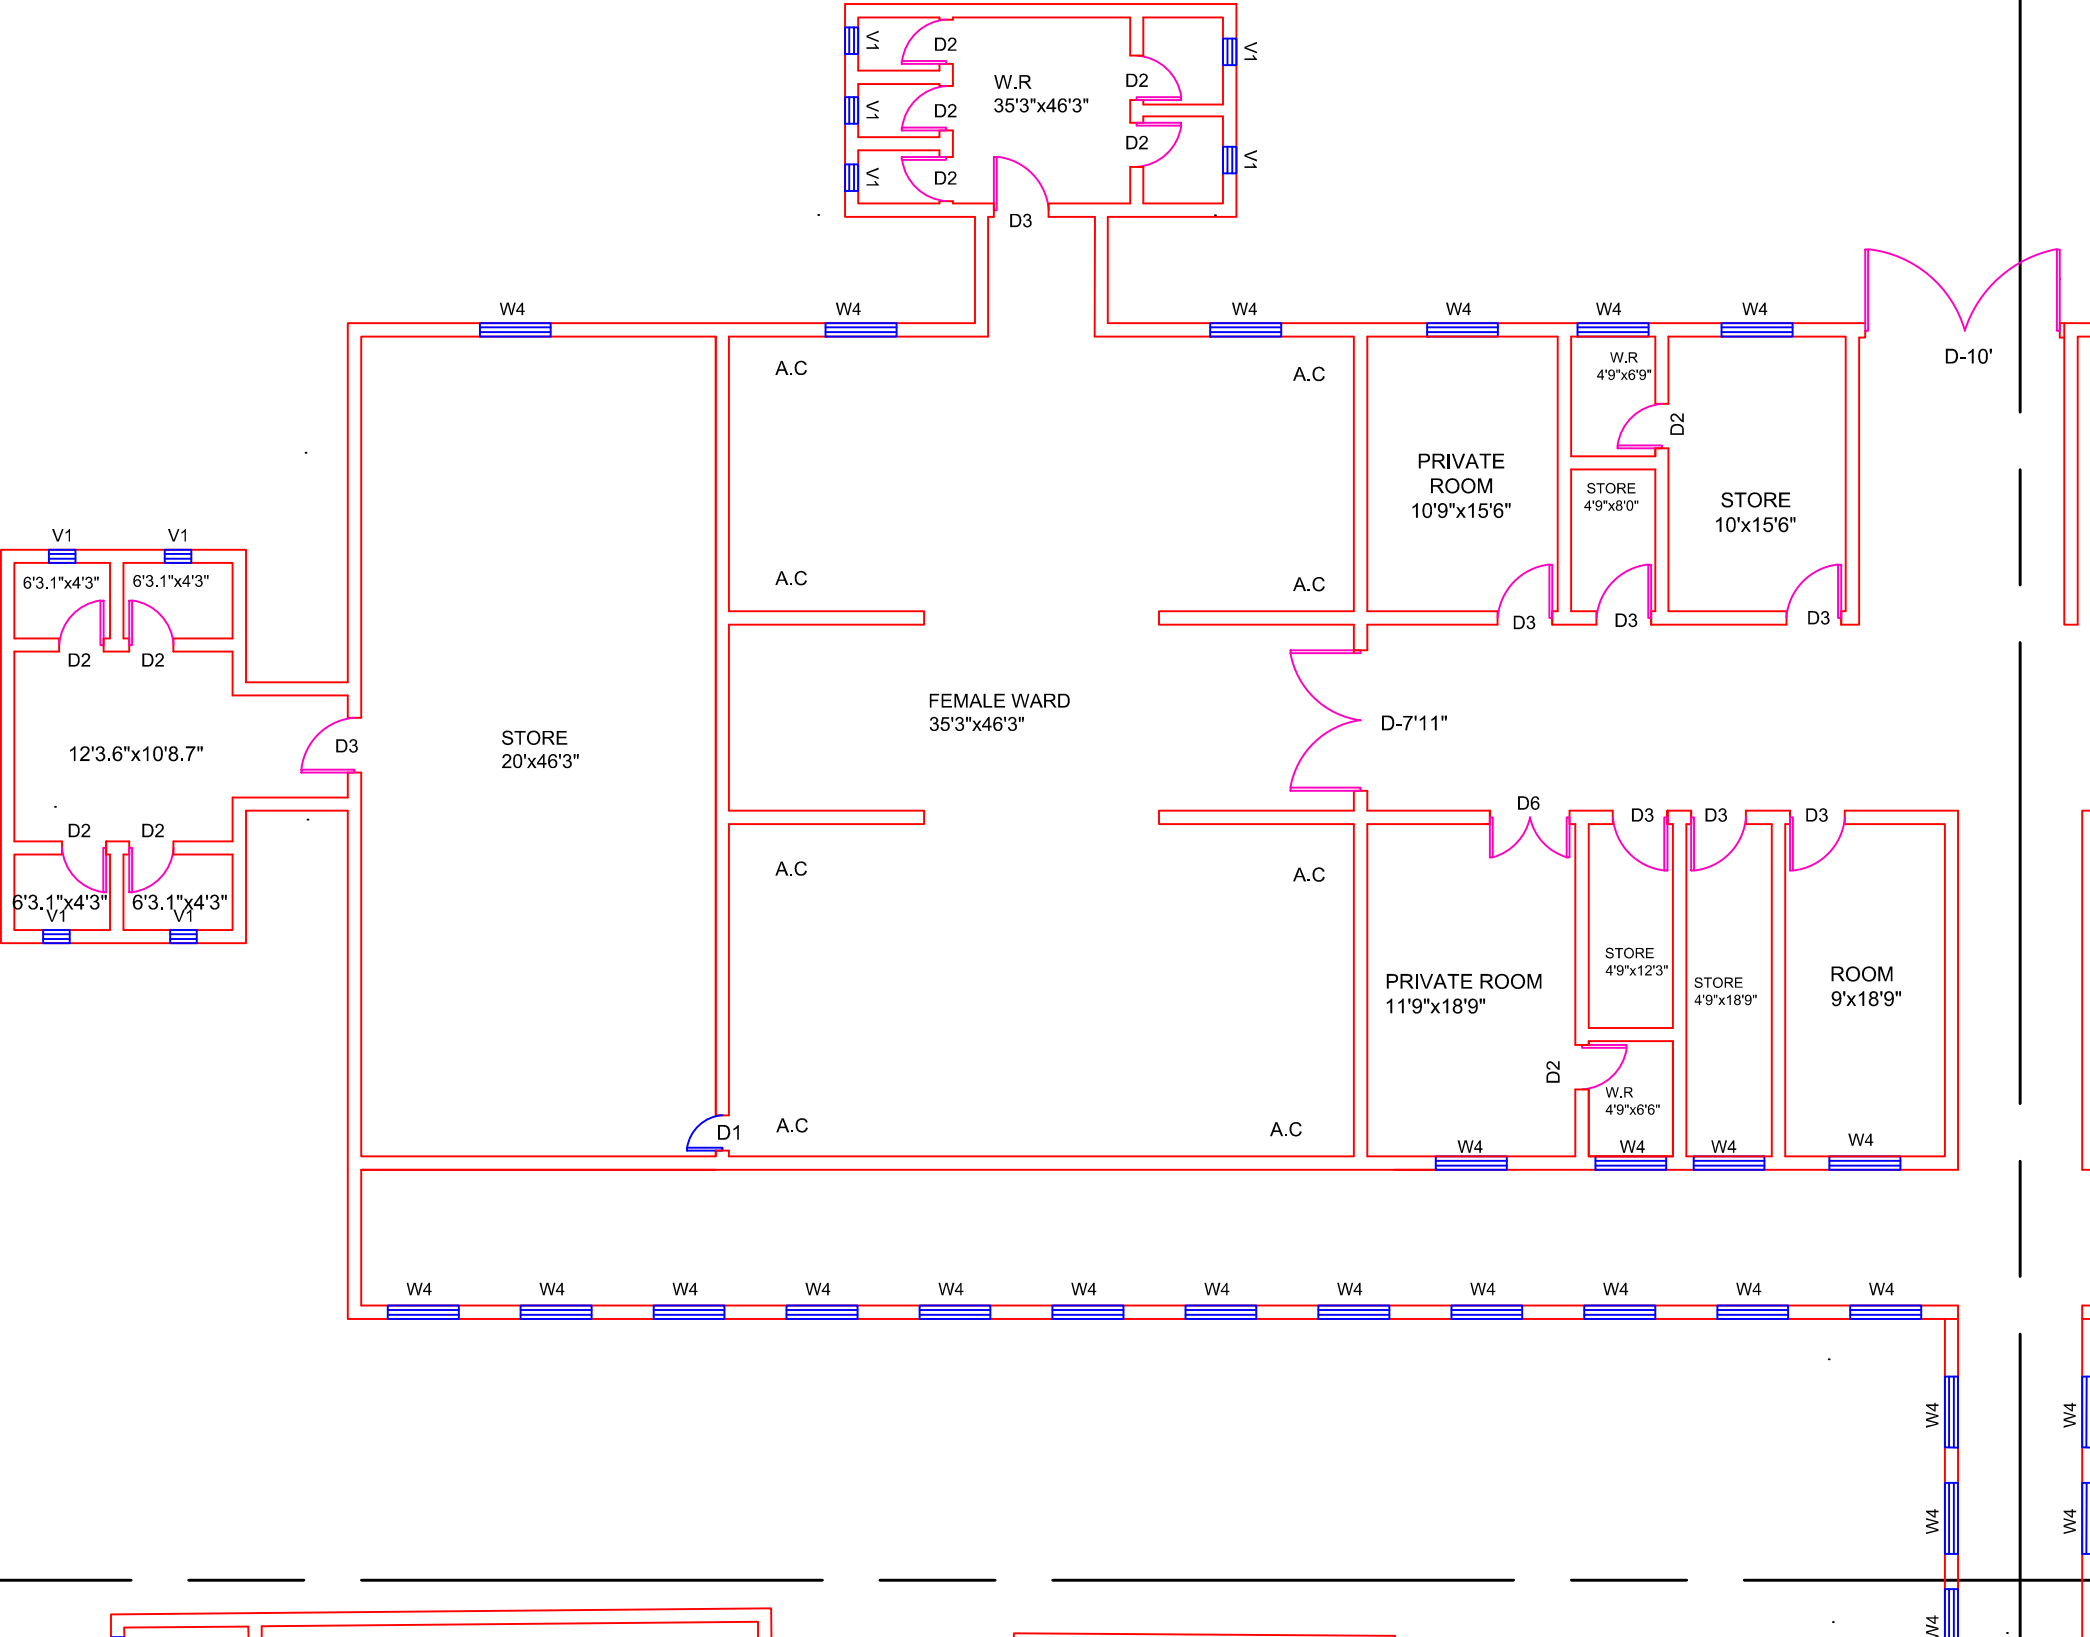

Legends:

Residential Area	
Road	
Wall	
Power Line	
OHT	
Tree	
Man Hole	
Tube Well	
Light Pole	
Lawns	
Earthen Areas	
Asphalts Roads	
Tough Pavers	
P.C.C / Plinth Protection	
Boundary Wall	
Brick Pavers / Soling	
Drain	
Tap	
Hand Pump	
Air Conditioner	
Tube Light	
Fan	
Roof Light	
Bulb	

AREA	
AREA WITHIN BOUNDARY WALL	351195.14 Sft
AREA OF CLINICAL BLOCK	21276.028 Sft
PLINTH AREA OF BLOCK	21276.028 Sft

OPENING SCHEDULE OF DOORS AND WINDOWS					
DOORS	WIDTH	HEIGHT	WINDOWS	WIDTH	HEIGHT
D1	5'-6"	7'-0"	W1	3'-0"	3'-0"
D2	5'-0"	7'-0"	W2	3'-6"	3'-6"
D3	4'-0"	7'-0"	W3	6'-0"	6'-0"
D4	3'-6"	7'-0"	W4	4'-6"	4'-6"
D5	3'-0"	7'-0"	W5	8'-6"	8'-6"
D6	2'-6"	7'-0"	W6	2'-6"	2'-6"
D7	6'-0"	7'-0"	W7	4'-0"	4'-0"
V1	1'-6"	1'-6"	V1	5'-0"	5'-0"
V2	2'-0"	2'-0"	V2	7'-0"	7'-0"

Project:
CAD MAPPING OF TEHSIL HEAD QUARTER HOSPITALS, PUNJAB

Client:

GOVERNMENT OF THE PUNJAB
PRIMARY & SECONDARY
HEALTHCARE DEPARTMENT

Consultant:


SKAFS CONSULTANT (Pvt.) Limited
ENGINEERING AND ENVIRONMENT CONSULTANT

Drawing Title:
THQ TALAGANG CLINICAL BLOCK PLAN (PART 1)

Drawing No.
SKAFS/TALAGANG /09

CLINICAL BLOCK OF THQ HOSPITAL TALAGANG

GROUND FLOOR PART 2

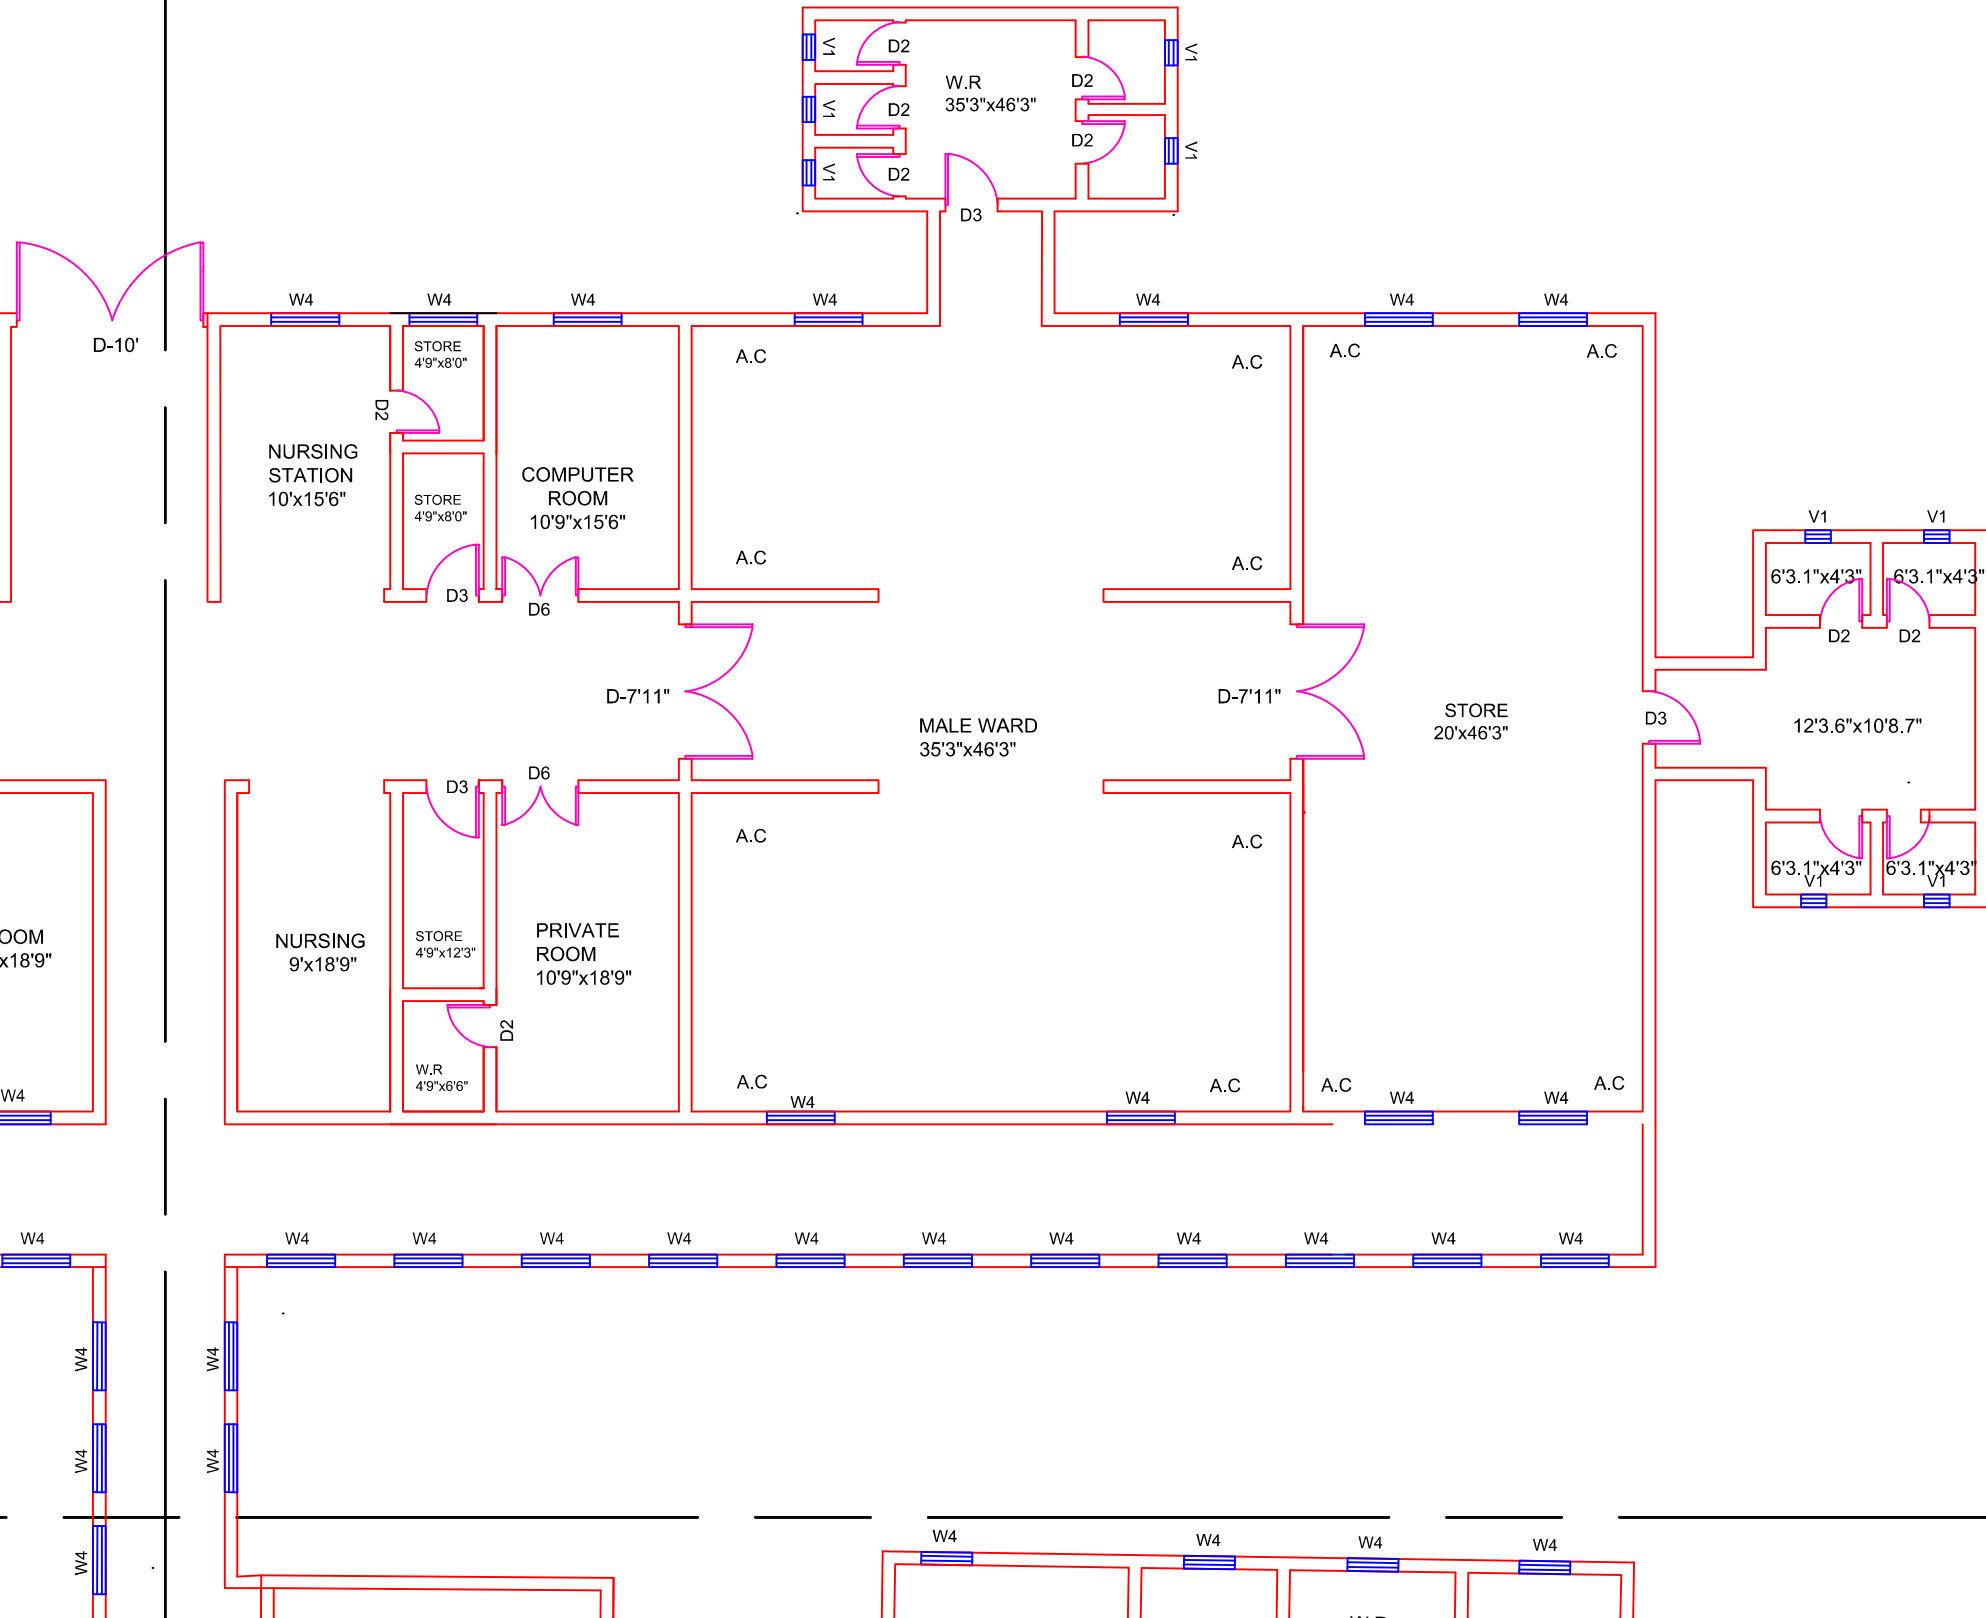

Legends:

Residential Area	
Road	
Wall	
Power Line	
OHT	
Tree	
Man Hole	
Tube Well	
Light Pole	
Lawns	
Earthen Areas	
Asphalts Roads	
Tough Pavers	
P.C.C / Plinth Protection	
Boundary Wall	
Brick Pavers / Soling	
Drain	
Tap	
Hand Pump	
Air Conditioner	
Tube Light	
Fan	
Roof Light	
Bulb	

AREA

AREA WITHIN BOUNDARY WALL	351195.14 Sft
AREA OF CLINICAL BLOCK	21276.028 Sft
PLINTH AREA OF BLOCK	21276.028 Sft

OPENING SCHEDULE OF DOORS AND WINDOWS

DOORS	WIDTH	HEIGHT	WINDOWS	WIDTH	HEIGHT
D1	5'-6"	7'-0"	W1	3'-0"	3'-0"
D2	5'-0"	7'-0"	W2	3'-6"	3'-6"
D3	4'-0"	7'-0"	W3	6'-0"	6'-0"
D4	3'-6"	7'-0"	W4	4'-6"	4'-6"
D5	3'-0"	7'-0"	W5	8'-6"	8'-6"
D6	2'-6"	7'-0"	W6	2'-6"	2'-6"
D7	6'-0"	7'-0"	W7	4'-0"	4'-0"
V1	1'-6"	1'-6"	V1	5'-0"	5'-0"
V2	2'-0"	2'-0"	V2	7'-0"	7'-0"

Project:
**CAD MAPPING OF TEHSIL
HEAD QUARTER HOSPITALS,
PUNJAB**


Client: GOVERNMENT OF THE PUNJAB PRIMARY & SECONDARY HEALTHCARE DEPARTMENT	Consultant: SKAFS CONSULTANT (Pvt.) Limited ENGINEERING AND ENVIRONMENT CONSULTANT
---	--

Drawing Title:
**THQ TALAGANG
CLINICAL BLOCK PLAN (PART 2)**

Drawing No.
SKAFS/TALAGANG /10

CLINICAL BLOCK OF THQ HOSPITAL TALAGANG

GROUND FLOOR PART 3

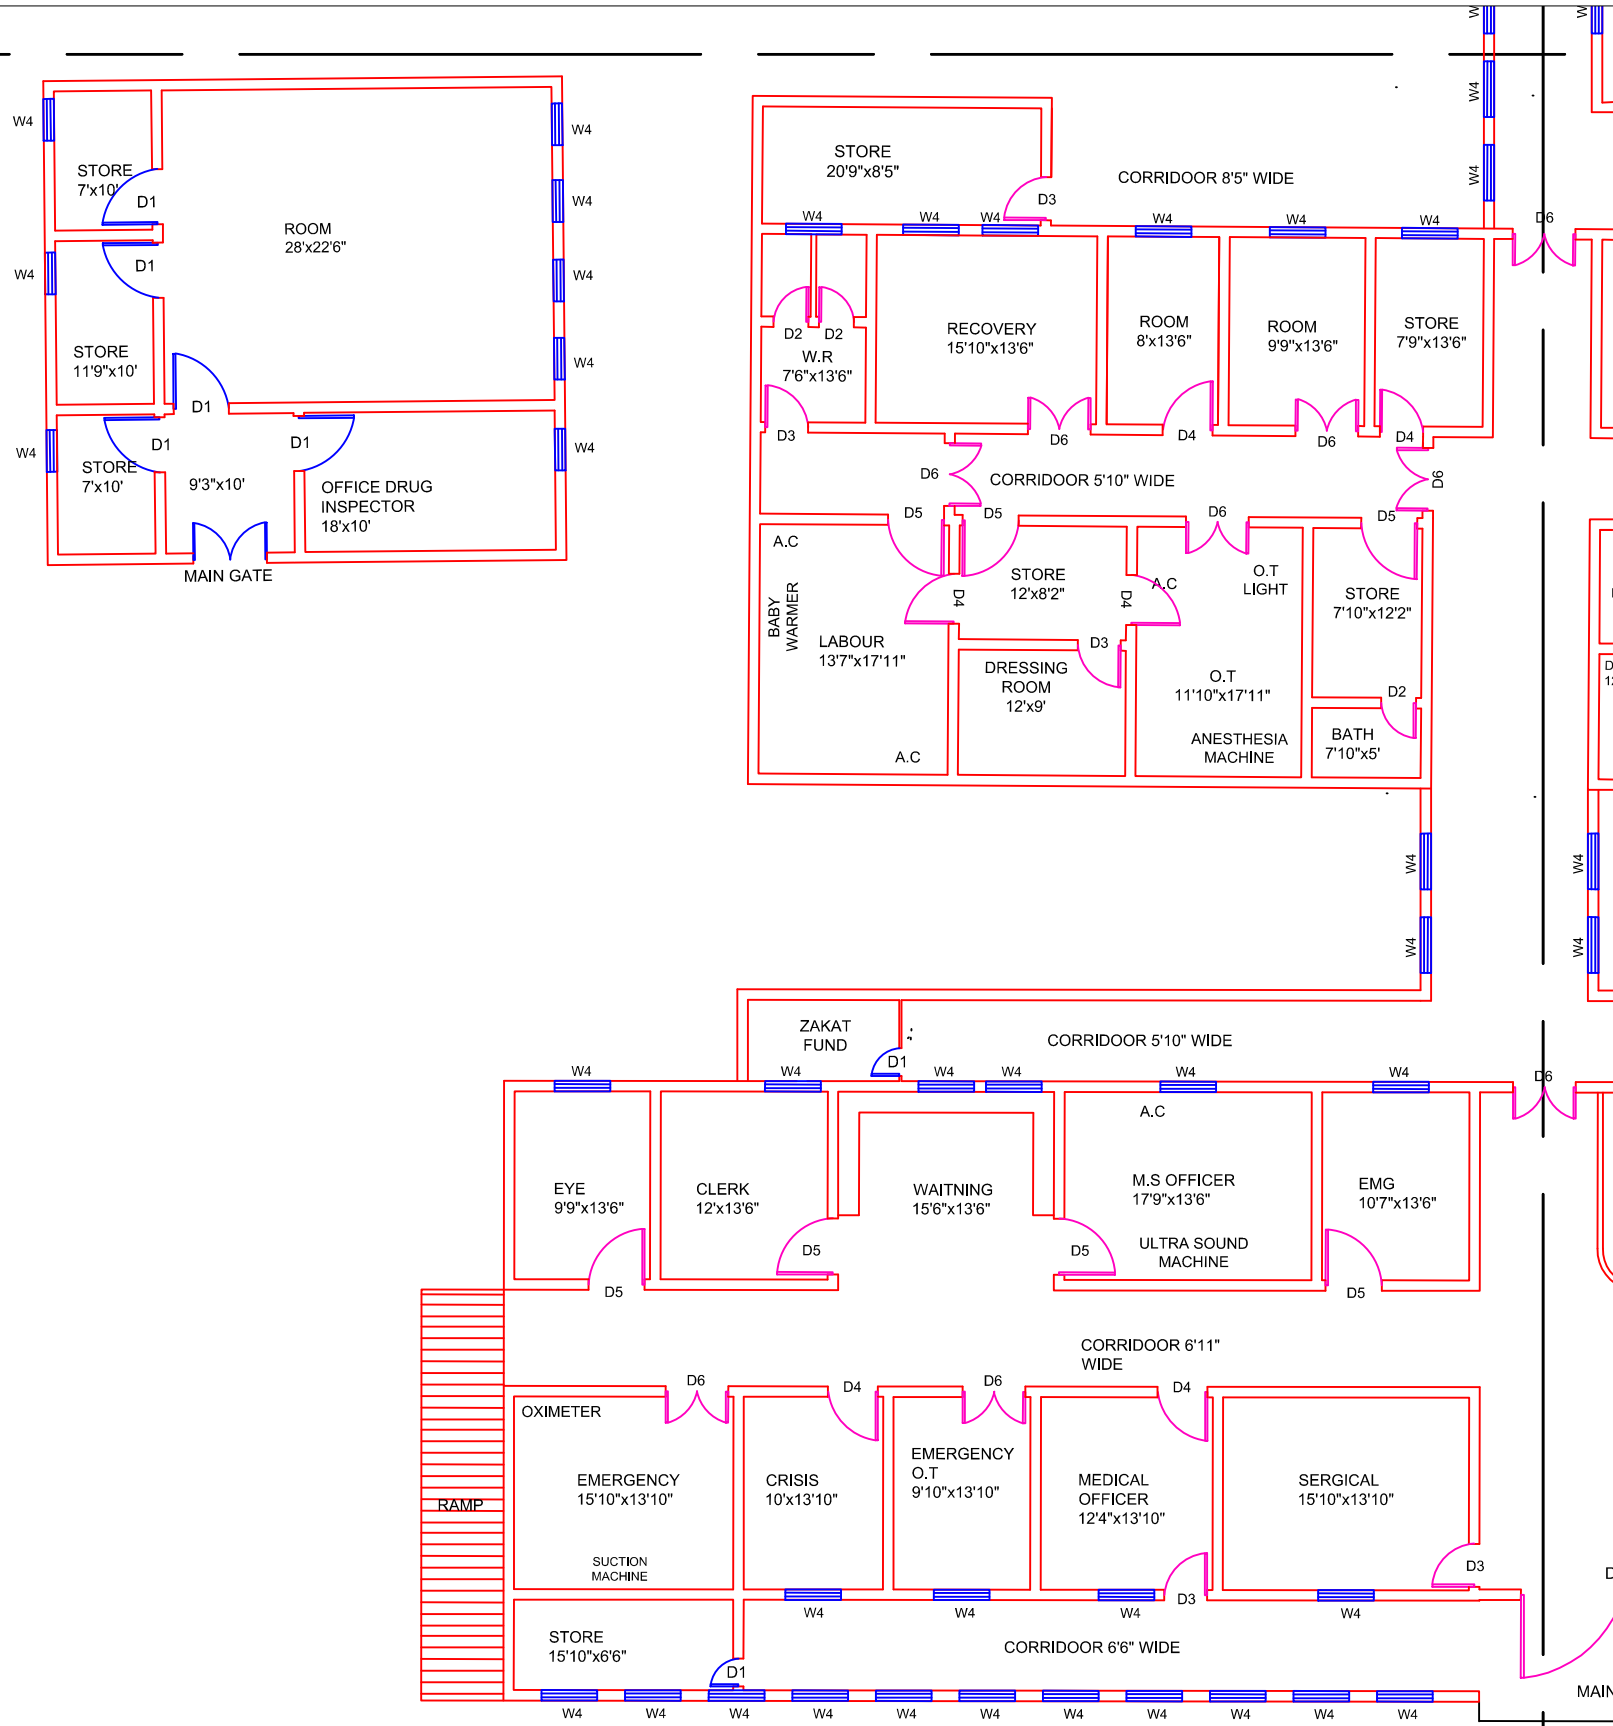

Legends:	
Residential Area	
Road	
Wall	
Power Line	
OHT	
Tree	
Man Hole	
Tube Well	
Light Pole	
Lawns	
Earthen Areas	
Asphalts Roads	
Tough Pavers	
P.C.C / Plinth Protection	
Boundary Wall	
Brick Pavers / Soling	
Drain	
Tap	
Hand Pump	
Air Conditioner	
Tube Light	
Fan	
Roof Light	
Bulb	

AREA	
AREA WITHIN BOUNDARY WALL	351195.14 Sft
AREA OF CLINICAL BLOCK	21276.028 Sft
PLINTH AREA OF BLOCK	21276.028 Sft

OPENING SCHEDULE OF DOORS AND WINDOWS					
DOORS	WIDTH	HEIGHT	WINDOWS	WIDTH	HEIGHT
D1	5'-6"	7'-0"	W1	3'-0"	3'-0"
D2	5'-0"	7'-0"	W2	3'-6"	3'-6"
D3	4'-0"	7'-0"	W3	6'-0"	6'-0"
D4	3'-6"	7'-0"	W4	4'-6"	4'-6"
D5	3'-0"	7'-0"	W5	8'-6"	8'-6"
D6	2'-6"	7'-0"	W6	2'-6"	2'-6"
D7	6'-0"	7'-0"	W7	4'-0"	4'-0"
V1	1'-6"	1'-6"	V1	5'-0"	5'-0"
V2	2'-0"	2'-0"	V2	7'-0"	7'-0"

Project:
**CAD MAPPING OF TEHSIL
HEAD QUARTER HOSPITALS,
PUNJAB**


Client: GOVERNMENT OF THE PUNJAB PRIMARY & SECONDARY HEALTHCARE DEPARTMENT	Consultant: SKAFS CONSULTANT (Pvt.) Limited ENGINEERING AND ENVIRONMENT CONSULTANT
---	--

Drawing Title:
**THQ TALAGANG
CLINICAL BLOCK PLAN (PART 3)**

Drawing No.
SKAFS/TALAGANG /11

CLINICAL BLOCK OF THQ HOSPITAL TALAGANG

GROUND FLOOR PART 4

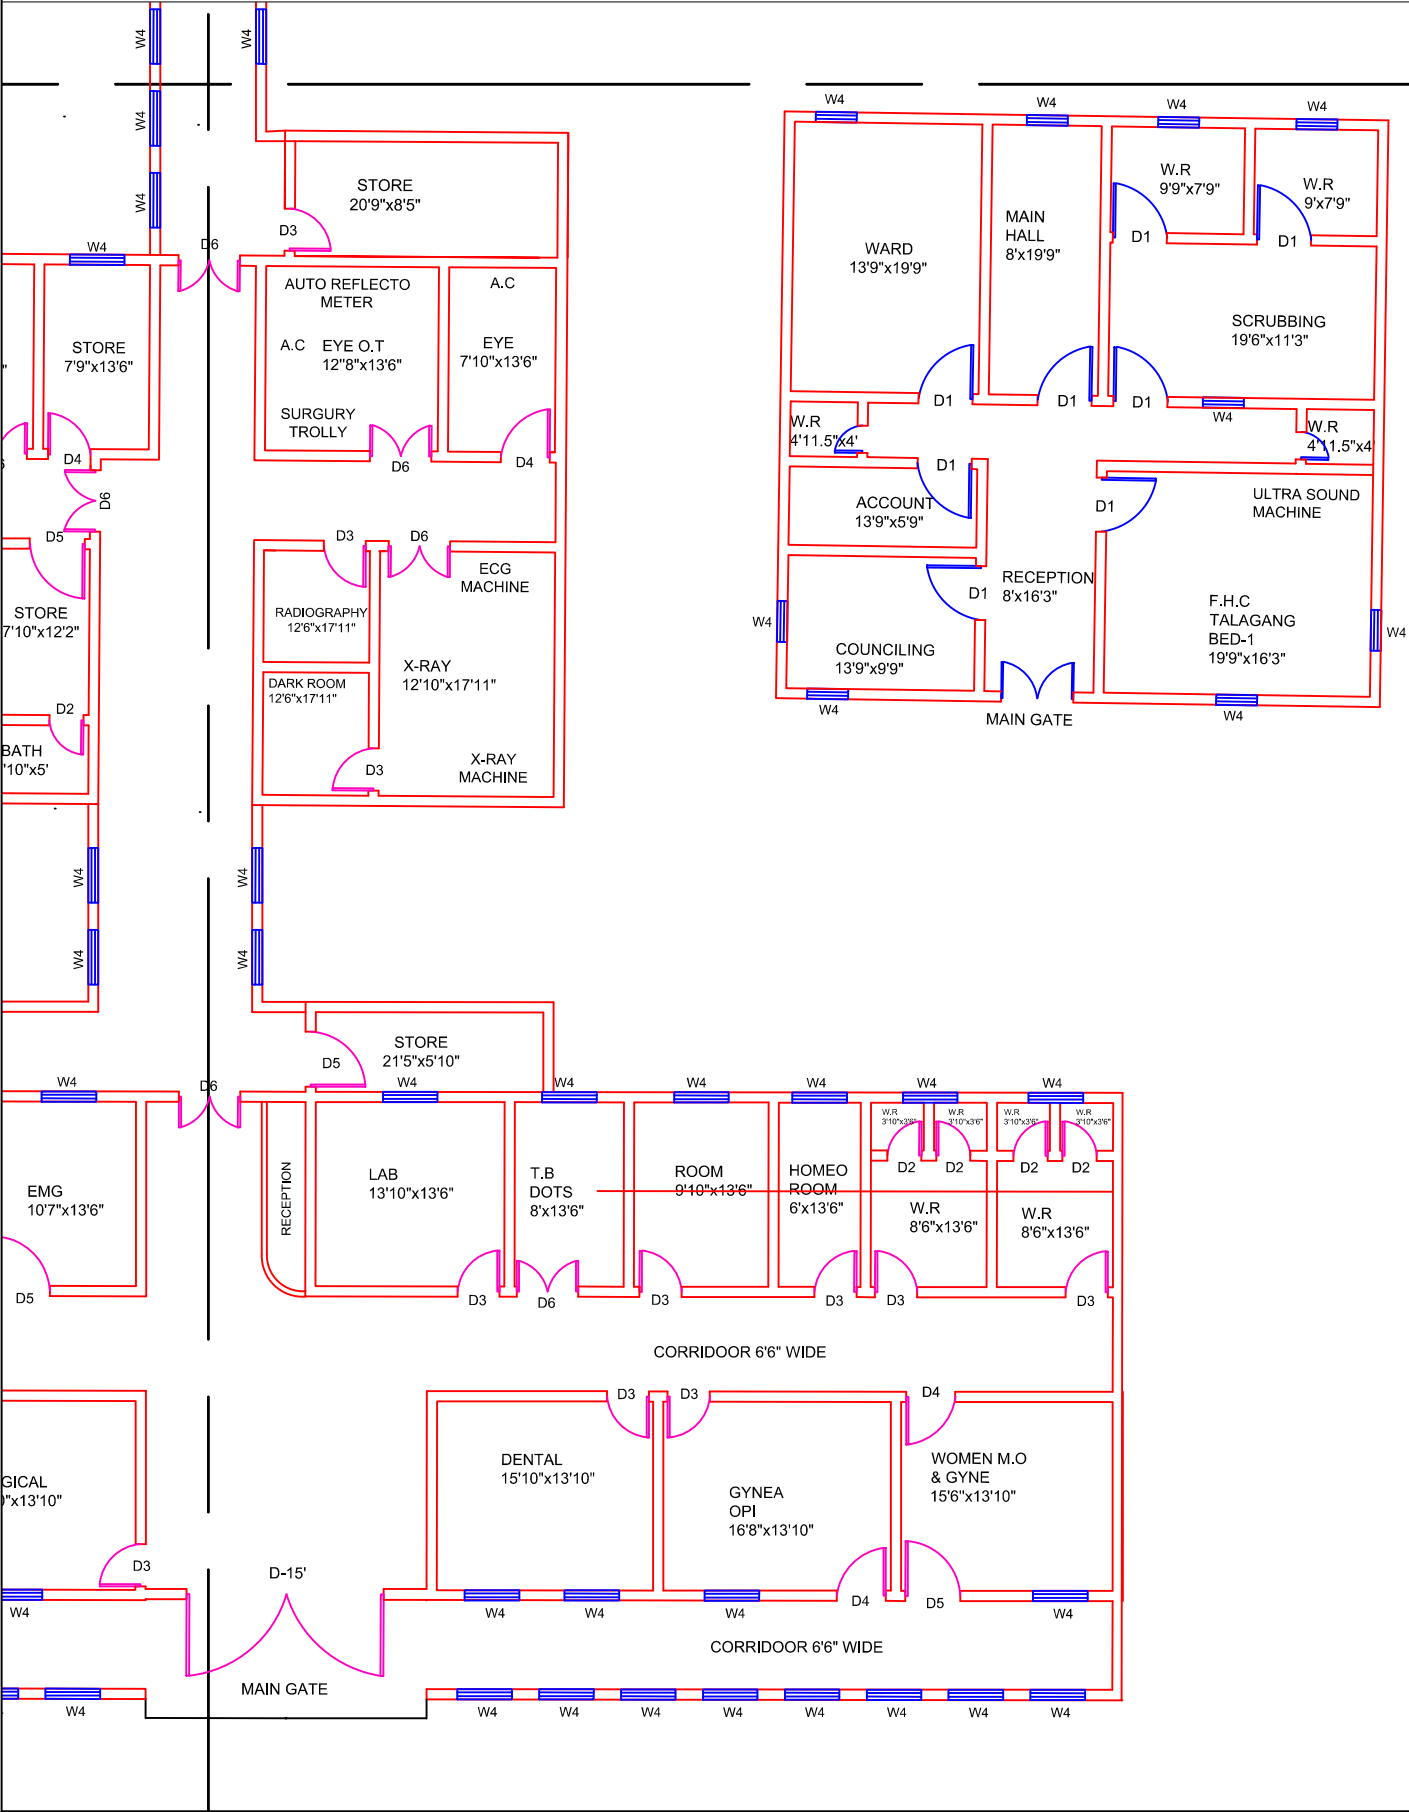

Legends:

Residential Area	
Road	
Wall	
Power Line	
OHT	
Tree	
Man Hole	
Tube Well	
Light Pole	
Lawns	
Earthen Areas	
Asphalts Roads	
Tough Pavers	
P.C.C / Plinth Protection	
Boundary Wall	
Brick Pavers / Soling	
Drain	
Tap	
Hand Pump	
Air Conditioner	
Tube Light	
Fan	
Roof Light	
Bulb	

AREA	
AREA WITHIN BOUNDARY WALL	351195.14 Sft
AREA OF CLINICAL BLOCK	21276.028 Sft
PLINTH AREA OF BLOCK	21276.028 Sft

OPENING SCHEDULE OF DOORS AND WINDOWS					
DOORS	WIDTH	HEIGHT	WINDOWS	WIDTH	HEIGHT
D1	5'-6"	7'-0"	W1	3'-0"	3'-0"
D2	5'-0"	7'-0"	W2	3'-6"	3'-6"
D3	4'-0"	7'-0"	W3	6'-0"	6'-0"
D4	3'-6"	7'-0"	W4	4'-6"	4'-6"
D5	3'-0"	7'-0"	W5	8'-6"	8'-6"
D6	2'-6"	7'-0"	W6	2'-6"	2'-6"
D7	6'-0"	7'-0"	W7	4'-0"	4'-0"
V1	1'-6"	1'-6"	V1	5'-0"	5'-0"
V2	2'-0"	2'-0"	V2	7'-0"	7'-0"

Project:
**CAD MAPPING OF TEHSIL
HEAD QUARTER HOSPITALS,
PUNJAB**

Client:

GOVERNMENT OF THE PUNJAB
PRIMARY & SECONDARY
HEALTHCARE DEPARTMENT


Consultant:

SKAFS CONSULTANT (Pvt.)
Limited
ENGINEERING AND ENVIRONMENT
CONSULTANT

Drawing Title:
**THQ TALAGANG
CLINICAL BLOCK PLAN (PART 4)**

Drawing No.
SKAFS/TALAGANG /12

ELECTRICAL LAYOUT PLAN OF THQ HOSPITAL TALAGANG GROUND FLOOR

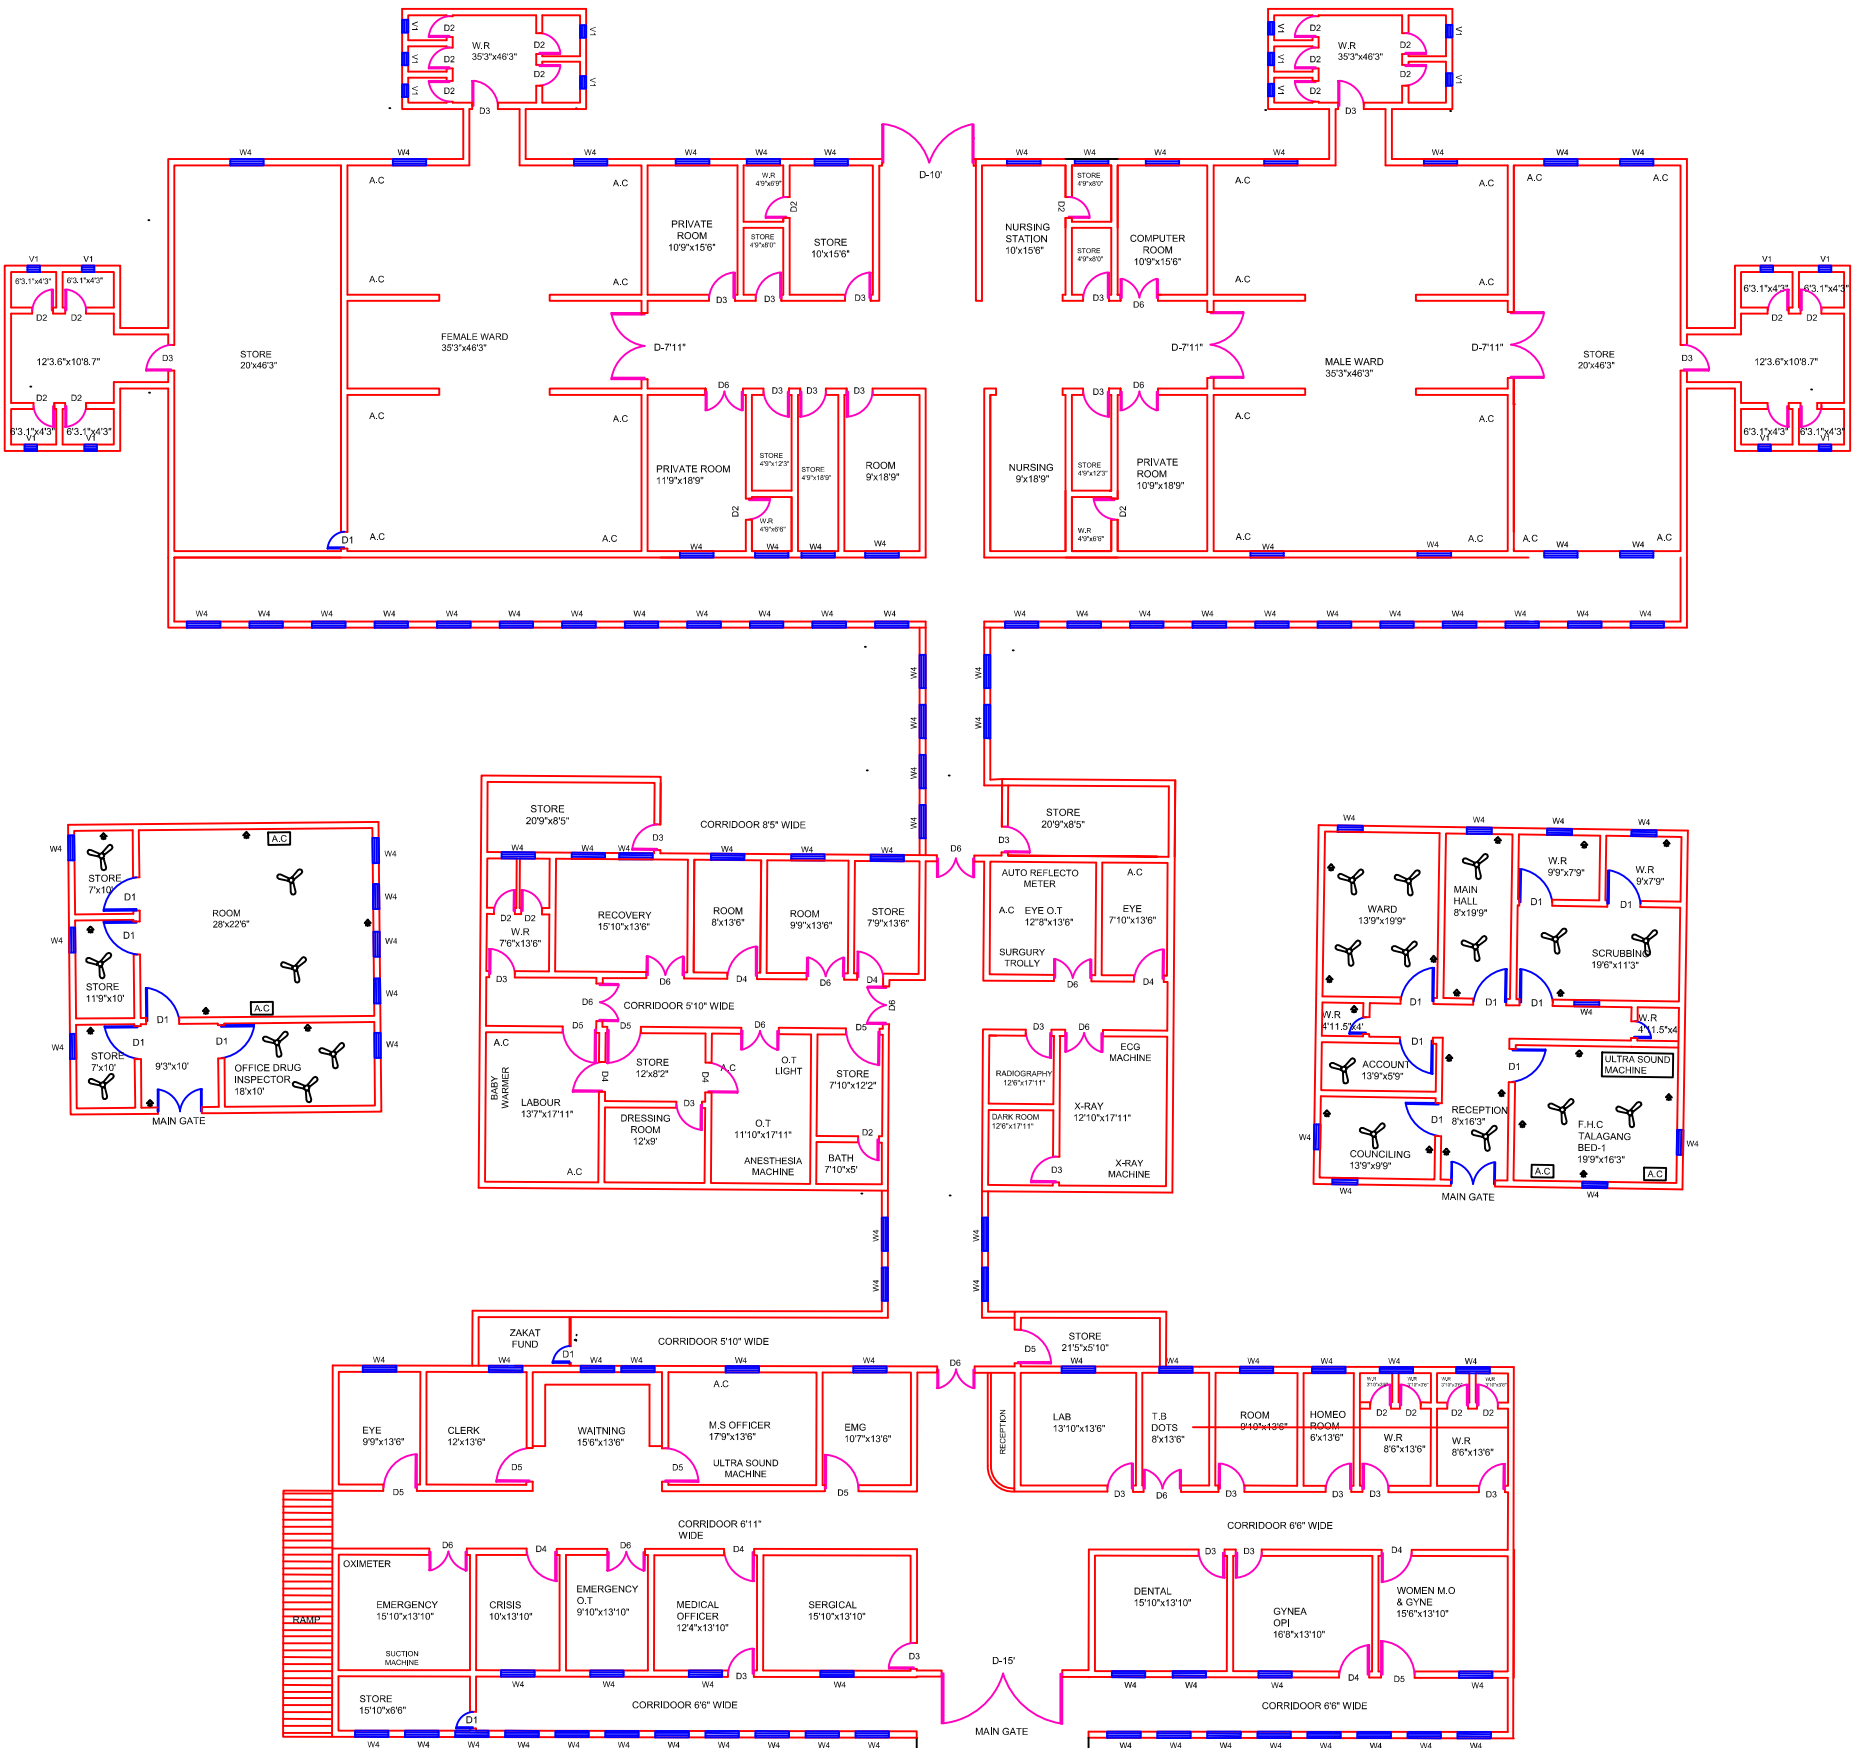

Legends:

Residential Area	
Road	
Wall	
Power Line	
OHT	
Tree	
Man Hole	
Tube Well	
Light Pole	
Lawns	
Earthen Areas	
Asphalts Roads	
Tough Pavers	
P.C.C / Plinth Protection	
Boundary Wall	
Brick Pavers / Soling	
Drain	
Tap	
Hand Pump	
Air Conditioner	
Tube Light	
Fan	
Roof Light	
Bulb	

AREA	
AREA WITHIN BOUNDARY WALL	351195.14 Sft
AREA OF CLINICAL BLOCK	21276.028 Sft
PLINTH AREA OF BLOCK	21276.028 Sft

OPENING SCHEDULE OF DOORS AND WINDOWS					
DOORS	WIDTH	HEIGHT	WINDOWS	WIDTH	HEIGHT
D1	5'-6"	7'-0"	W1	3'-0"	3'-0"
D2	5'-0"	7'-0"	W2	3'-6"	3'-6"
D3	4'-0"	7'-0"	W3	6'-0"	6'-0"
D4	3'-6"	7'-0"	W4	4'-6"	4'-6"
D5	3'-0"	7'-0"	W5	8'-6"	8'-6"
D6	2'-6"	7'-0"	W6	2'-6"	2'-6"
D7	6'-0"	7'-0"	W7	4'-0"	4'-0"
V1	1'-6"	1'-6"	V1	5'-0"	5'-0"
V2	2'-0"	2'-0"	V2	7'-0"	7'-0"

Project:

CAD MAPPING OF TEHSIL
HEAD QUARTER HOSPITALS,
PUNJAB

Client:

GOVERNMENT OF THE PUNJAB
PRIMARY & SECONDARY
HEALTHCARE DEPARTMENT

Consultant:

SKAFS CONSULTANT (Pvt.)
Limited
ENGINEERING AND ENVIRONMENT
CONSULTANT

Drawing Title:

THQ TALAGANG
ELECTRICAL PLAN (GROUND FLOOR)

Drawing No.

SKAFS/TALAGANG /13