



MASTER PLAN OF THQ HOSPITAL TAXILA

PART 1

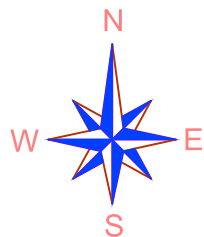

PART 2

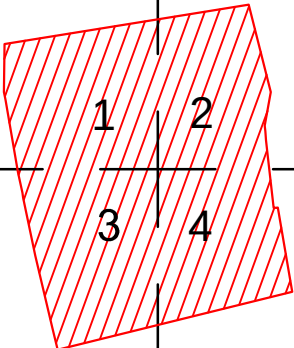

PART 3



PART 4

KHANPUR ROAD

Legends:

Residential Area	
Road	
Wall	
Power Line	
OHT	
Tree	
Man Hole	
Tube Well	
Light Pole	
Lawns	
Earthen Areas	
Asphalts Roads	
Tough Pavers	
P.C.C / Plinth Protection	
Boundary Wall	
Brick Pavers / Soling	
Drain	
Tap	
Hand Pump	
Air Conditioner	
Tube Light	
Fan	
Roof Light	
Bulb	

AREA	
AREA WITHIN BOUNDARY WALL	185928.87 Sft
AREA OF CLINICAL BLOCK	33377.22 Sft
PLINTH AREA OF BLOCK	33377.22 Sft

OPENING SCHEDULE OF DOORS AND WINDOWS					
DOORS	WIDTH	HEIGHT	WINDOWS	WIDTH	HEIGHT
D1	3'-6"	7'-0"	W1	4'-0"	5'-6"
D2	4'-0"	7'-0"	W2	4'-3"	8'-0"
D3	3'-0"	7'-0"	W3	8'-3"	8'-0"
D4	2'-6"	7'-0"	W4	2'-0"	2'-0"
D5	4'-6"	7'-0"	W5	4'-0"	4'-0"
D6	5'-0"	7'-0"	W6	5'-6"	8'-0"
D7	5'-4"	7'-0"	W7	6'-0"	4'-0"
D8	6'-0"	7'-0"	V1		
D9	7'-0"	7'-0"	V2		

Project:
**CAD MAPPING OF TEHSIL
HEAD QUARTER HOSPITALS,
PUNJAB**

Client:	Consultant:
 GOVERNMENT OF THE PUNJAB PRIMARY & SECONDARY HEALTHCARE DEPARTMENT	 SKAFS CONSULTANT (Pvt.) Limited ENGINEERING AND ENVIRONMENT CONSULTANT

Drawing Title:
**THQ TAXILA
HOSPITAL MASTER PLAN**

Drawing No.
SKAFS/TAXILA /03

MASTER PLAN OF THQ HOSPITAL TAXILA

PART 1



Legends:

Residential Area	
Road	
Wall	
Power Line	
OHT	
Tree	
Man Hole	
Tube Well	
Light Pole	
Lawns	
Earthen Areas	
Asphalts Roads	
Tough Pavers	
P.C.C / Plinth Protection	
Boundary Wall	
Brick Pavers / Soling	
Drain	
Tap	
Hand Pump	
Air Conditioner	
Tube Light	
Fan	
Roof Light	
Bulb	

AREA	
AREA WITHIN BOUNDARY WALL	185928.87 Sft
AREA OF CLINICAL BLOCK	33377.22 Sft
PLINTH AREA OF BLOCK	33377.22 Sft

OPENING SCHEDULE OF DOORS AND WINDOWS					
DOORS	WIDTH	HEIGHT	WINDOWS	WIDTH	HEIGHT
D1	3'-6"	7'-0"	W1	4'-0"	5'-6"
D2	4'-0"	7'-0"	W2	4'-3"	8'-0"
D3	3'-0"	7'-0"	W3	8'-3"	8'-0"
D4	2'-6"	7'-0"	W4	2'-0"	2'-0"
D5	4'-6"	7'-0"	W5	4'-0"	4'-0"
D6	5'-0"	7'-0"	W6	5'-6"	8'-0"
D7	5'-4"	7'-0"	W7	6'-0"	4'-0"
D8	6'-0"	7'-0"	V1		
D9	7'-0"	7'-0"	V2		


Project:
**CAD MAPPING OF TEHSIL
HEAD QUARTER HOSPITALS,
PUNJAB**

Client: GOVERNMENT OF THE PUNJAB PRIMARY & SECONDARY HEALTHCARE DEPARTMENT	Consultant: SKAFS CONSULTANT (Pvt.) Limited ENGINEERING AND ENVIRONMENT CONSULTANT
---	--

Drawing Title:
**THQ TAXILA
HOSPITAL MASTER PLAN PART 1**

Drawing No.
SKAFS/TAXILA /04

MASTER PLAN OF THQ HOSPITAL TAXILA
PART 2

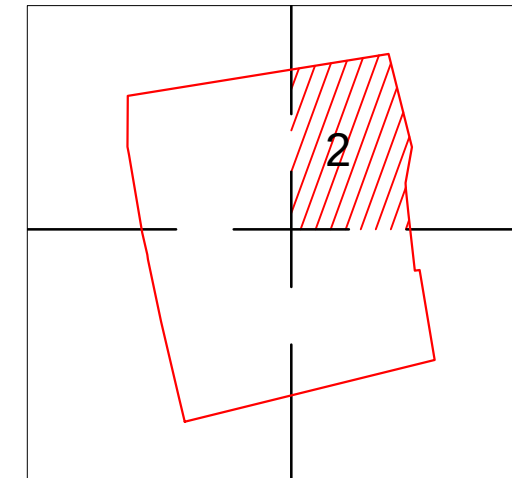

Legends:

Residential Area	
Road	
Wall	
Power Line	
OHT	
Tree	
Man Hole	
Tube Well	
Light Pole	
Lawns	
Earthen Areas	
Asphalts Roads	
Tough Pavers	
P.C.C / Plinth Protection	
Boundary Wall	
Brick Pavers / Soling	
Drain	
Tap	
Hand Pump	
Air Conditioner	
Tube Light	
Fan	
Roof Light	
Bulb	

AREA	
AREA WITHIN BOUNDARY WALL	185928.87 Sft
AREA OF CLINICAL BLOCK	33377.22 Sft
PLINTH AREA OF BLOCK	33377.22 Sft

OPENING SCHEDULE OF DOORS AND WINDOWS					
DOORS	WIDTH	HEIGHT	WINDOWS	WIDTH	HEIGHT
D1	3'-6"	7'-0"	W1	4'-0"	5'-6"
D2	4'-0"	7'-0"	W2	4'-3"	8'-0"
D3	3'-0"	7'-0"	W3	8'-3"	8'-0"
D4	2'-6"	7'-0"	W4	2'-0"	2'-0"
D5	4'-6"	7'-0"	W5	4'-0"	4'-0"
D6	5'-0"	7'-0"	W6	5'-6"	8'-0"
D7	5'-4"	7'-0"	W7	6'-0"	4'-0"
D8	6'-0"	7'-0"	V1		
D9	7'-0"	7'-0"	V2		

Project:
**CAD MAPPING OF TEHSIL
HEAD QUARTER HOSPITALS,
PUNJAB**

Client:  GOVERNMENT OF THE PUNJAB PRIMARY & SECONDARY HEALTHCARE DEPARTMENT	Consultant:  SKAFS CONSULTANT (Pvt.) Limited ENGINEERING AND ENVIRONMENT CONSULTANT
--	---

Drawing Title: **THQ TAXILA
HOSPITAL MASTER PLAN PART 2**

Drawing No. SKAFS/TAXILA /05

MASTER PLAN OF THQ HOSPITAL TAXILA

PART 3



Legends:

Residential Area	
Road	
Wall	
Power Line	
OHT	
Tree	
Man Hole	
Tube Well	
Light Pole	
Lawns	
Earthen Areas	
Asphalts Roads	
Tough Pavers	
P.C.C / Plinth Protection	
Boundary Wall	
Brick Pavers / Soling	
Drain	
Tap	
Hand Pump	
Air Conditioner	
Tube Light	
Fan	
Roof Light	
Bulb	

AREA	
AREA WITHIN BOUNDARY WALL	185928.87 Sft
AREA OF CLINICAL BLOCK	33377.22 Sft
PLINTH AREA OF BLOCK	33377.22 Sft

OPENING SCHEDULE OF DOORS AND WINDOWS					
DOORS	WIDTH	HEIGHT	WINDOWS	WIDTH	HEIGHT
D1	3'-6"	7'-0"	W1	4'-0"	5'-6"
D2	4'-0"	7'-0"	W2	4'-3"	8'-0"
D3	3'-0"	7'-0"	W3	8'-3"	8'-0"
D4	2'-6"	7'-0"	W4	2'-0"	2'-0"
D5	4'-6"	7'-0"	W5	4'-0"	4'-0"
D6	5'-0"	7'-0"	W6	5'-6"	8'-0"
D7	5'-4"	7'-0"	W7	6'-0"	4'-0"
D8	6'-0"	7'-0"	V1		
D9	7'-0"	7'-0"	V2		

Project:
CAD MAPPING OF TEHSIL HEAD QUARTER HOSPITALS, PUNJAB

Client:

GOVERNMENT OF THE PUNJAB
PRIMARY & SECONDARY
HEALTHCARE DEPARTMENT

Consultant:


SKAFS CONSULTANT (Pvt.) Limited
ENGINEERING AND ENVIRONMENT
CONSULTANT

Drawing Title:
THQ TAXILA HOSPITAL MASTER PLAN PART 3


Drawing No.
SKAFS/TAXILA /06

MASTER PLAN OF THQ HOSPITAL TAXILA

PART 4

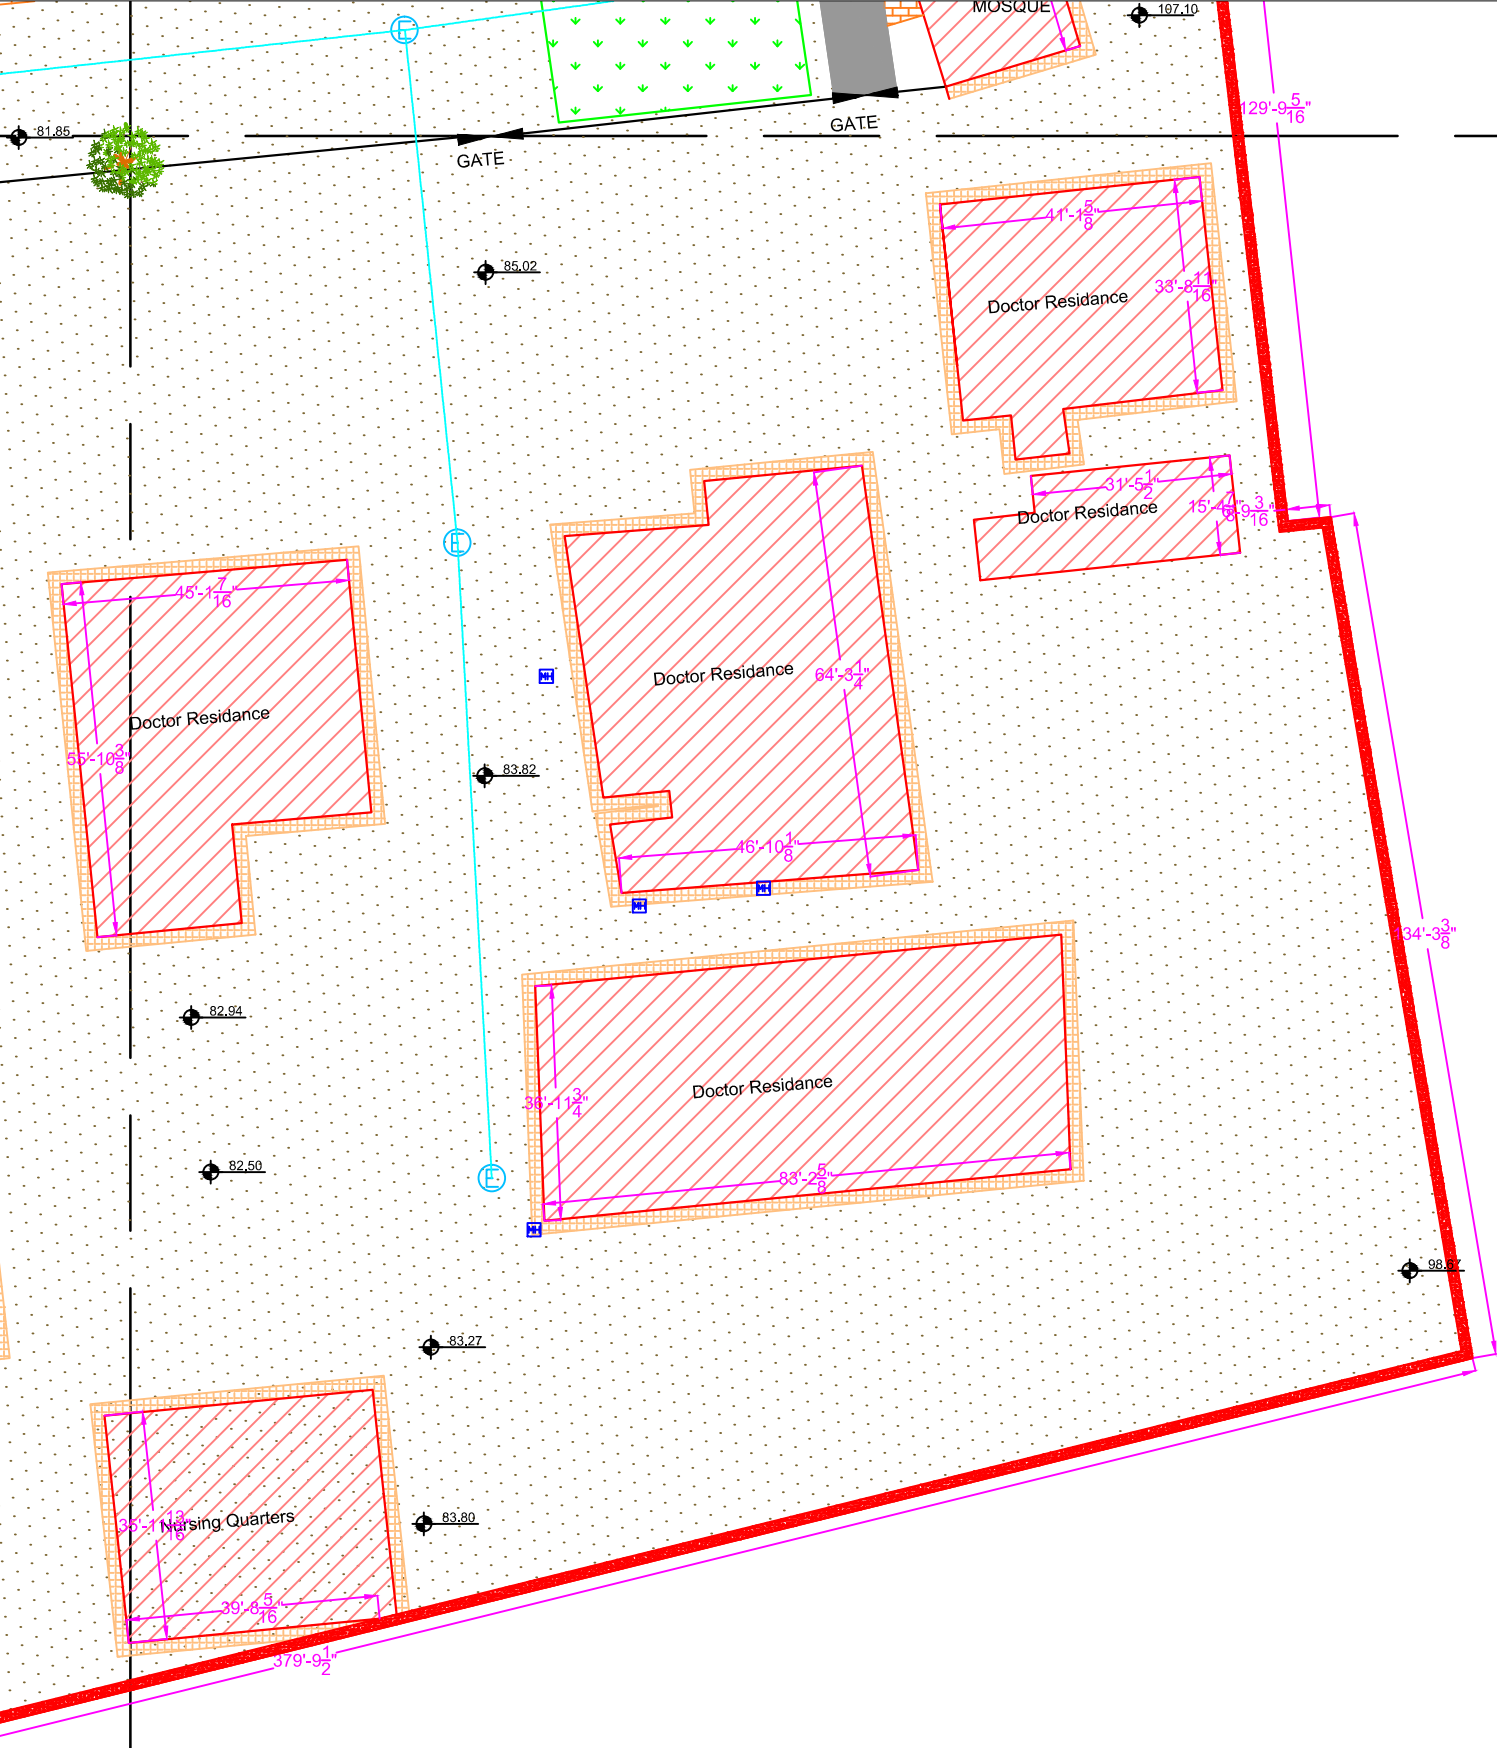

KHANPUR ROAD

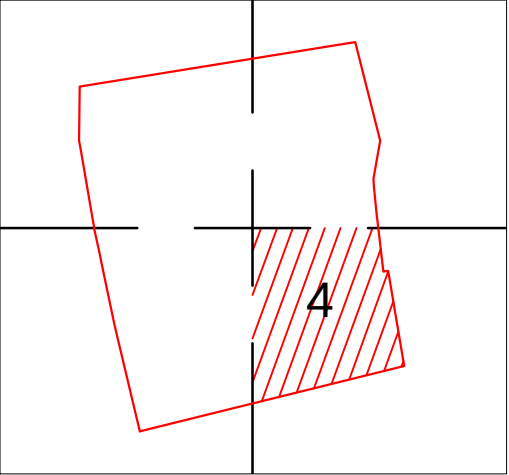

Legends:	
Residential Area	
Road	
Wall	
Power Line	
OHT	
Tree	
Man Hole	
Tube Well	
Light Pole	
Lawns	
Earthen Areas	
Asphalts Roads	
Tough Pavers	
P.C.C / Plinth Protection	
Boundary Wall	
Brick Pavers / Soling	
Drain	
Tap	
Hand Pump	
Air Conditioner	
Tube Light	
Fan	
Roof Light	
Bulb	

AREA	
AREA WITHIN BOUNDARY WALL	185928.87 Sft
AREA OF CLINICAL BLOCK	33377.22 Sft
PLINTH AREA OF BLOCK	33377.22 Sft

OPENING SCHEDULE OF DOORS AND WINDOWS					
DOORS	WIDTH	HEIGHT	WINDOWS	WIDTH	HEIGHT
D1	3'-6"	7'-0"	W1	4'-0"	5'-6"
D2	4'-0"	7'-0"	W2	4'-3"	8'-0"
D3	3'-0"	7'-0"	W3	8'-3"	8'-0"
D4	2'-6"	7'-0"	W4	2'-0"	2'-0"
D5	4'-6"	7'-0"	W5	4'-0"	4'-0"
D6	5'-0"	7'-0"	W6	5'-6"	8'-0"
D7	5'-4"	7'-0"	W7	6'-0"	4'-0"
D8	6'-0"	7'-0"	V1		
D9	7'-0"	7'-0"	V2		

Project:
**CAD MAPPING OF TEHSIL
HEAD QUARTER HOSPITALS,
PUNJAB**

Client: GOVERNMENT OF THE PUNJAB PRIMARY & SECONDARY HEALTHCARE DEPARTMENT	Consultant: SKAFS CONSULTANT (Pvt.) Limited ENGINEERING AND ENVIRONMENT CONSULTANT
---	--

Drawing Title:
**THQ TAXILA
HOSPITAL MASTER PLAN PART 4**


Drawing No.
SKAFS/TAXILA /07

CLINICAL BLOCK OF THQ HOSPITAL TAXILA

GROUND FLOOR

PART 1

PART 2

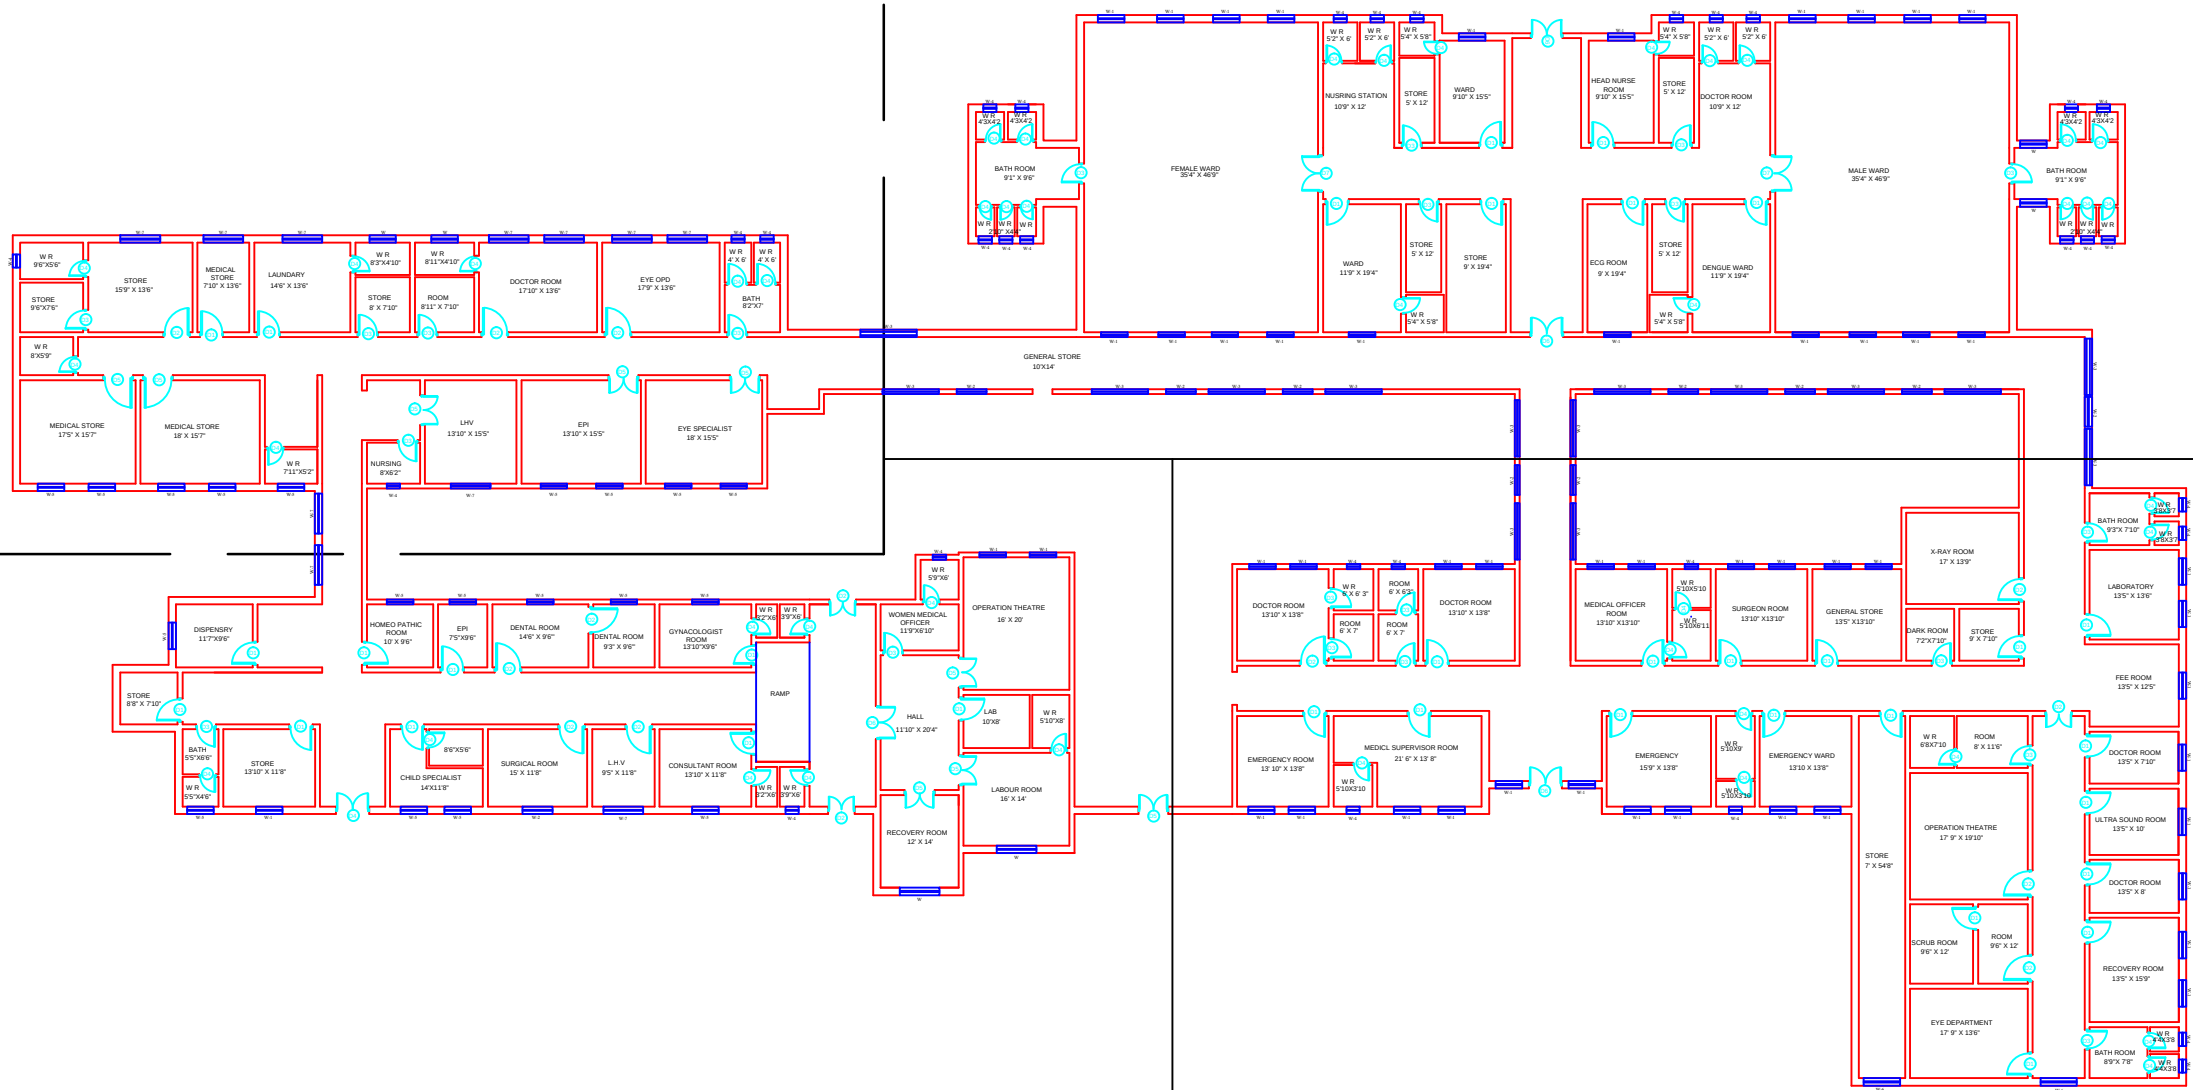

PART 3

PART 4

Legends:	
Residential Area	
Road	
Wall	
Power Line	
OHT	
Tree	
Man Hole	
Tube Well	
Light Pole	
Lawns	
Earthen Areas	
Asphalts Roads	
Tough Pavers	
P.C.C / Plinth Protection	
Boundary Wall	
Brick Pavers / Soling	
Drain	
Tap	
Hand Pump	
Air Conditioner	
Tube Light	
Fan	
Roof Light	
Bulb	

AREA	
AREA WITHIN BOUNDARY WALL	185928.87 Sft
AREA OF CLINICAL BLOCK	33377.22 Sft
PLINTH AREA OF BLOCK	33377.22 Sft

OPENING SCHEDULE OF DOORS AND WINDOWS					
DOORS	WIDTH	HEIGHT	WINDOWS	WIDTH	HEIGHT
D1	3'-6"	7'-0"	W1	4'-0"	5'-6"
D2	4'-0"	7'-0"	W2	4'-3"	8'-0"
D3	3'-0"	7'-0"	W3	8'-3"	8'-0"
D4	2'-6"	7'-0"	W4	2'-0"	2'-0"
D5	4'-6"	7'-0"	W5	4'-0"	4'-0"
D6	5'-0"	7'-0"	W6	5'-6"	8'-0"
D7	5'-4"	7'-0"	W7	6'-0"	4'-0"
D8	6'-0"	7'-0"	V1		
D9	7'-0"	7'-0"	V2		

Project:
**CAD MAPPING OF TEHSIL
HEAD QUARTER HOSPITALS,
PUNJAB**

Client: GOVERNMENT OF THE PUNJAB PRIMARY & SECONDARY HEALTHCARE DEPARTMENT	Consultant: SKAFS CONSULTANT (Pvt.) Limited ENGINEERING AND ENVIRONMENT CONSULTANT
---	--

Drawing Title:
**THQ TAXILA
HOSPITAL CLINICAL BLOCK PLAN**

Drawing No.
SKAFS/TAXILA /08

CLINICAL BLOCK OF THQ HOSPITAL TAXILA

GROUND FLOOR PART 1

Legends:

Residential Area	
Road	
Wall	
Power Line	
OHT	
Tree	
Man Hole	
Tube Well	
Light Pole	
Lawns	
Earthen Areas	
Asphalts Roads	
Tough Pavers	
P.C.C / Plinth Protection	
Boundary Wall	
Brick Pavers / Soling	
Drain	
Tap	
Hand Pump	
Air Conditioner	
Tube Light	
Fan	
Roof Light	
Bulb	

AREA	
AREA WITHIN BOUNDARY WALL	185928.87 Sft
AREA OF CLINICAL BLOCK	33377.22 Sft
PLINTH AREA OF BLOCK	33377.22 Sft

OPENING SCHEDULE OF DOORS AND WINDOWS					
DOORS	WIDTH	HEIGHT	WINDOWS	WIDTH	HEIGHT
D1	3'-6"	7'-0"	W1	4'-0"	5'-6"
D2	4'-0"	7'-0"	W2	4'-3"	8'-0"
D3	3'-0"	7'-0"	W3	8'-3"	8'-0"
D4	2'-6"	7'-0"	W4	2'-0"	2'-0"
D5	4'-6"	7'-0"	W5	4'-0"	4'-0"
D6	5'-0"	7'-0"	W6	5'-6"	8'-0"
D7	5'-4"	7'-0"	W7	6'-0"	4'-0"
D8	6'-0"	7'-0"	V1		
D9	7'-0"	7'-0"	V2		

Project:
CAD MAPPING OF TEHSIL HEAD QUARTER HOSPITALS, PUNJAB

Client:


GOVERNMENT OF THE PUNJAB
PRIMARY & SECONDARY
HEALTHCARE DEPARTMENT

Consultant:


SKAFS CONSULTANT (Pvt.) Limited
ENGINEERING AND ENVIRONMENT
CONSULTANT

Drawing Title:
**THQ TAXILA
CLINICAL BLOCK PLAN (PART 1)**

Drawing No.
SKAFS/TAXILA /09

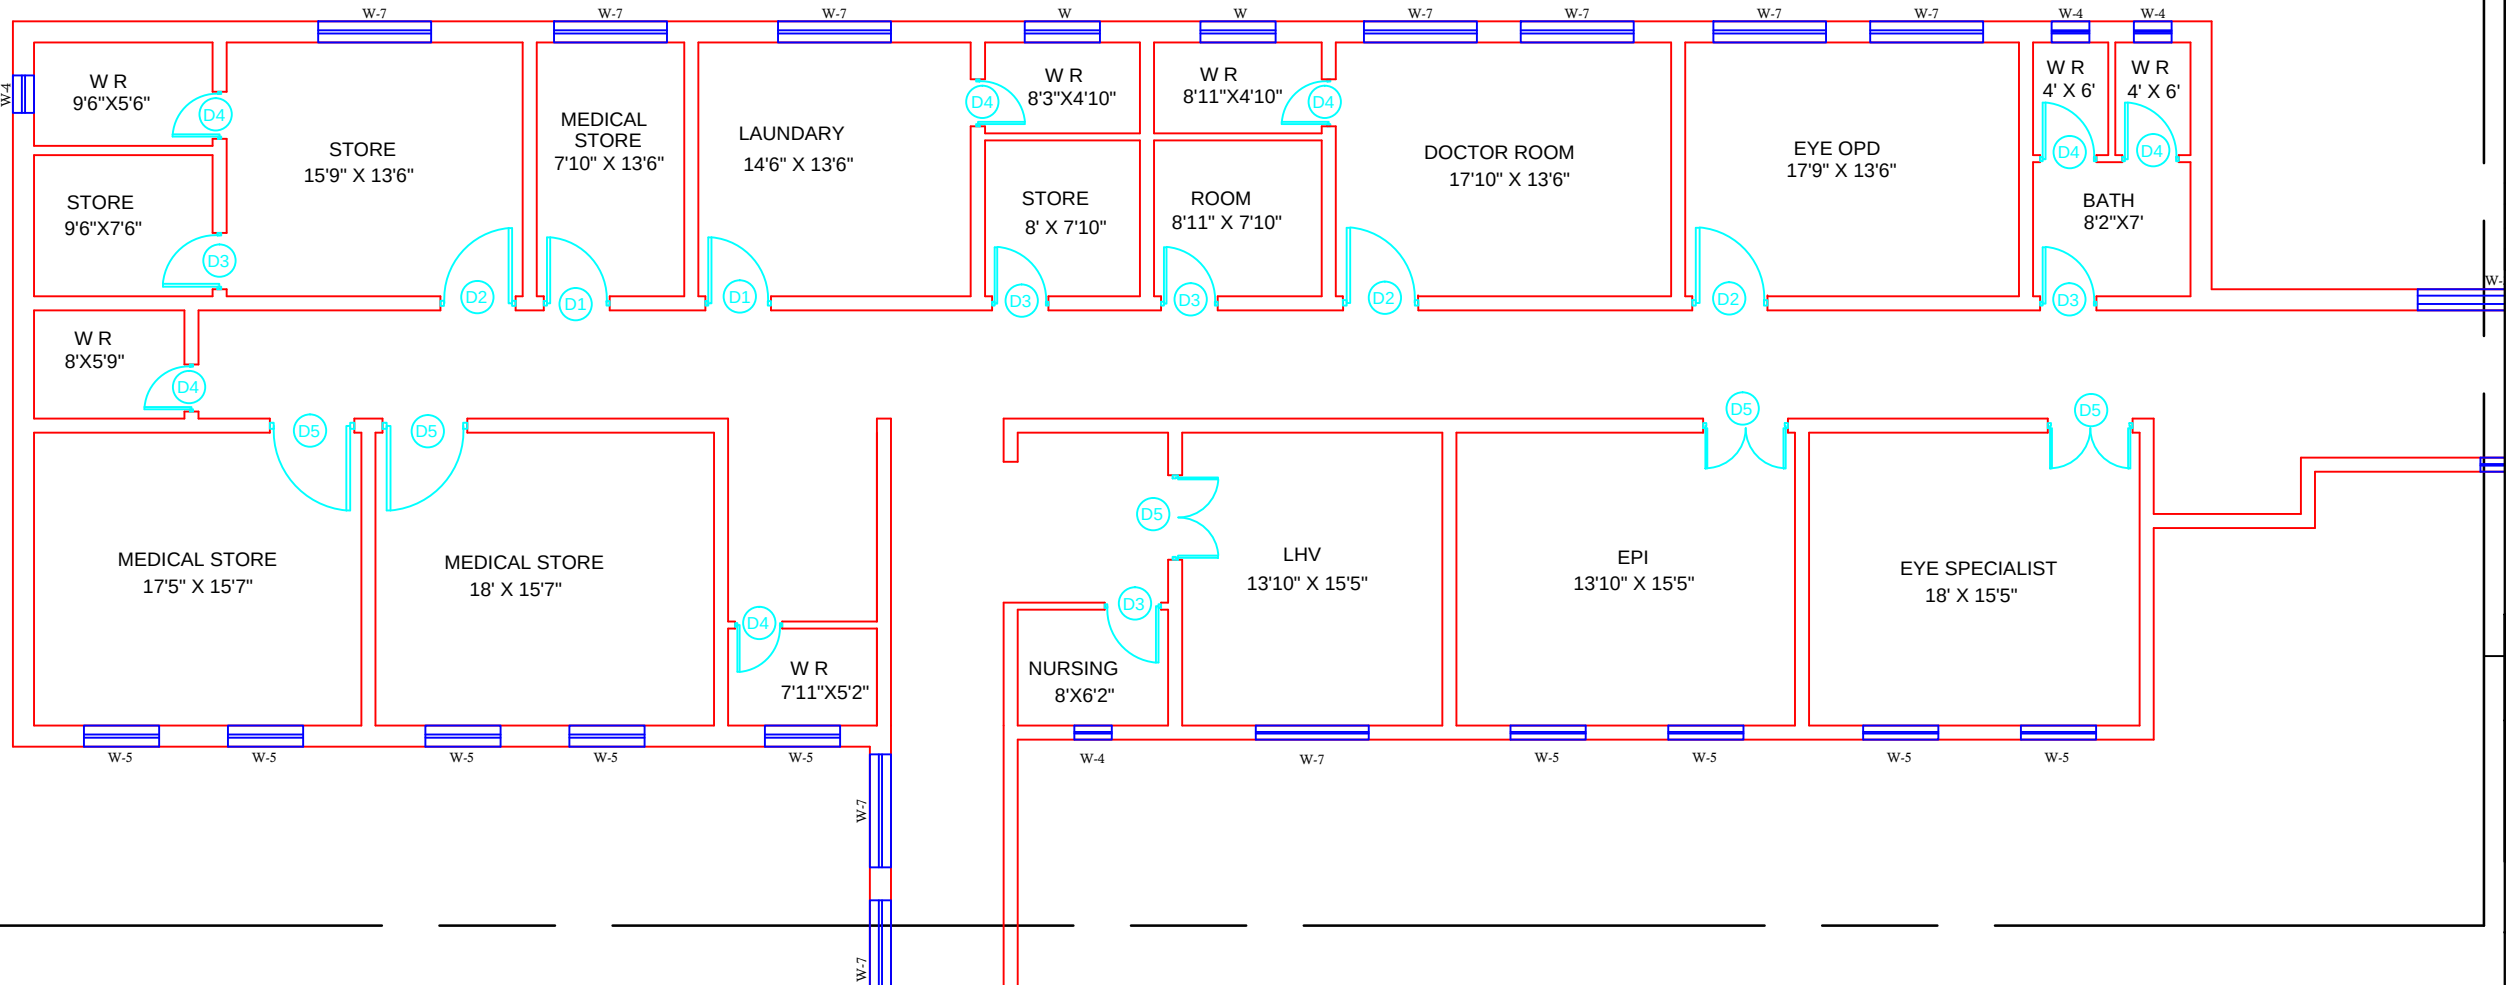

CLINICAL BLOCK OF THQ HOSPITAL TAXILA
GROUND FLOOR PART 2

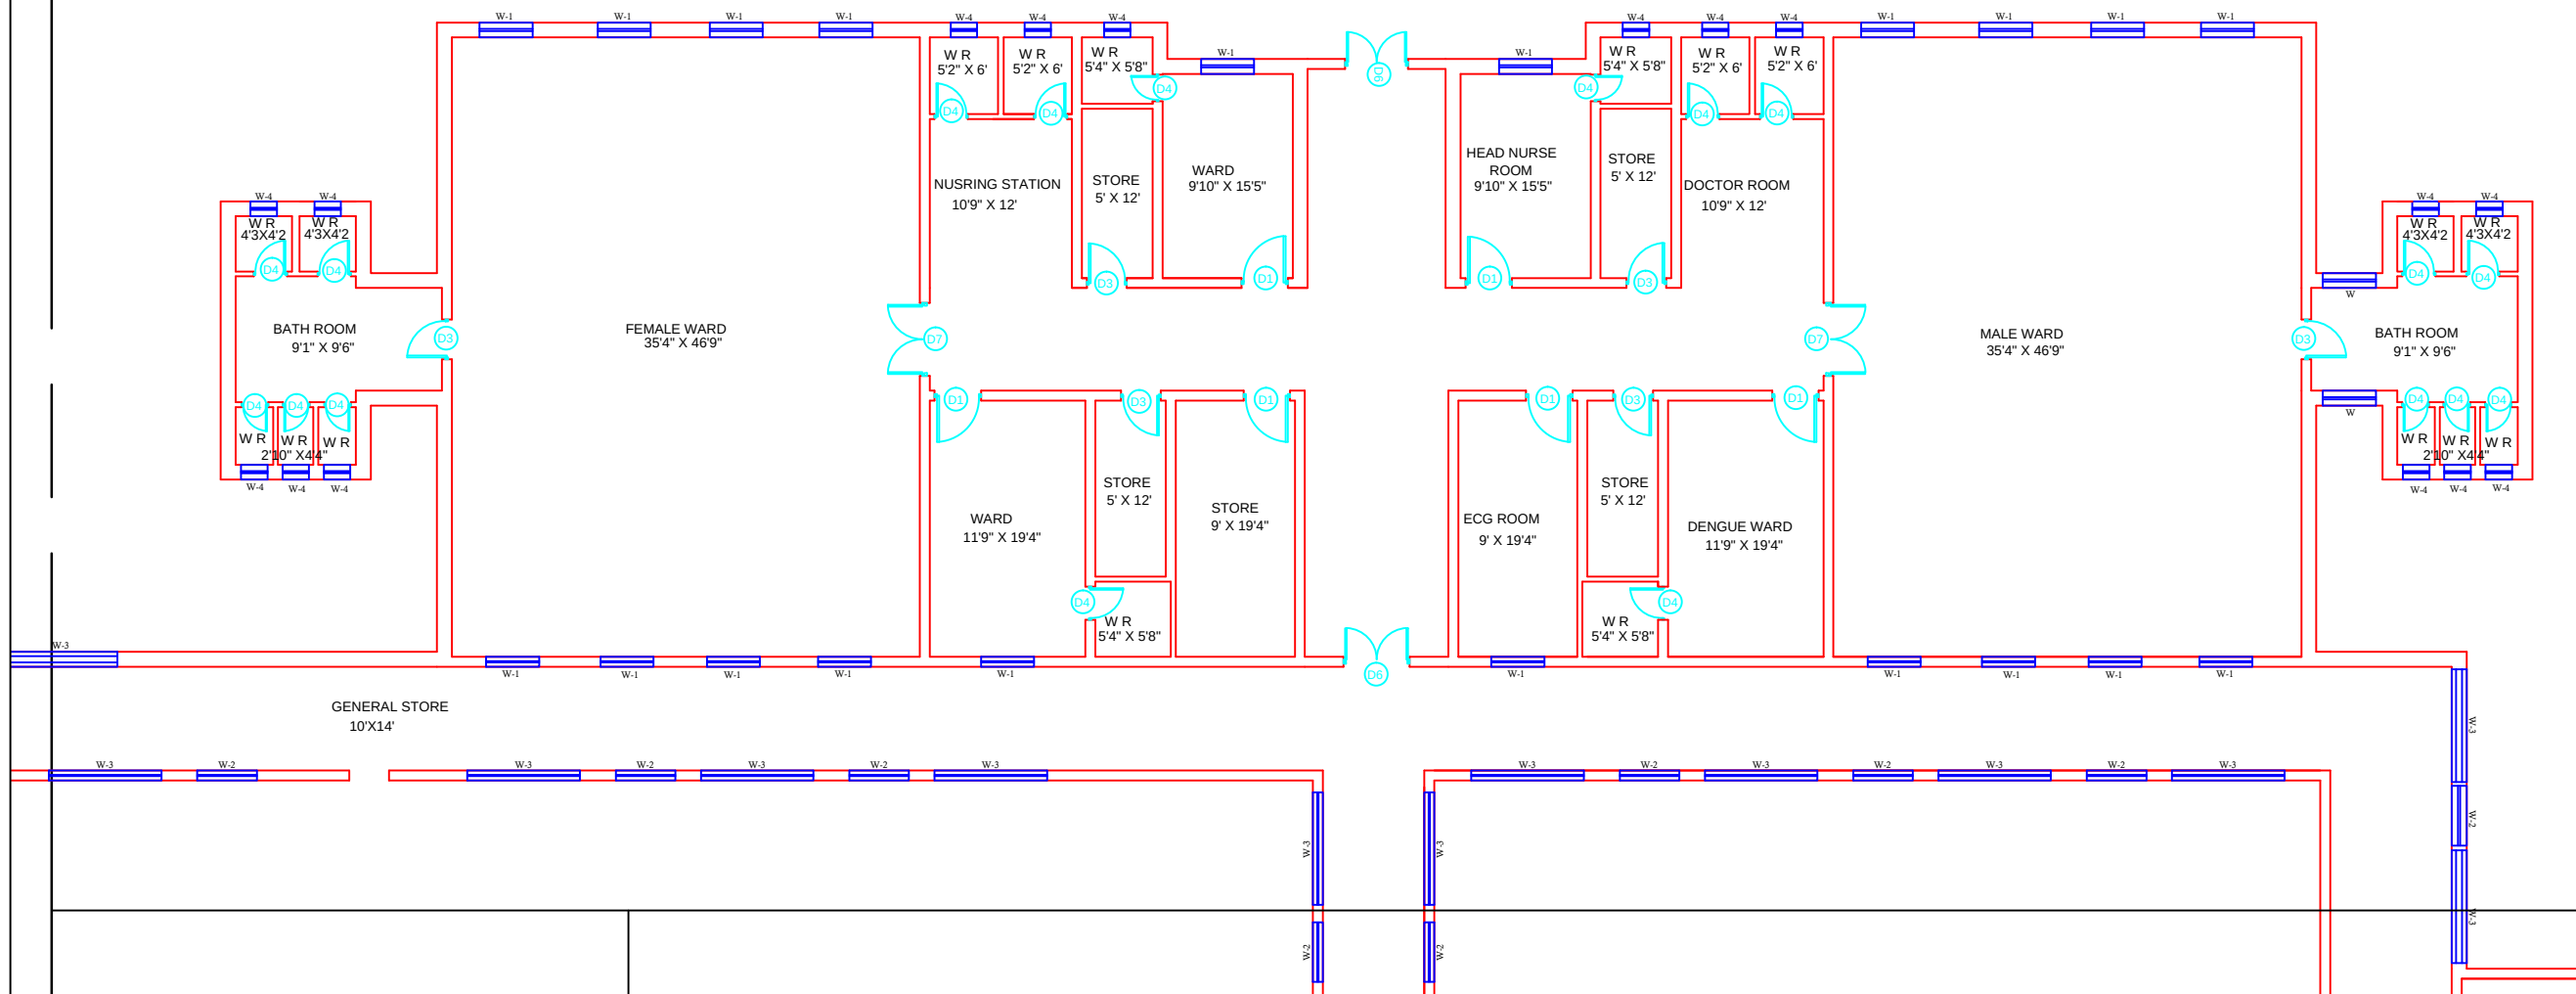

Legends:

Residential Area	
Road	
Wall	
Power Line	
OHT	
Tree	
Man Hole	
Tube Well	
Light Pole	
Lawns	
Earthen Areas	
Asphalts Roads	
Tough Pavers	
P.C.C / Plinth Protection	
Boundary Wall	
Brick Pavers / Soling	
Drain	
Tap	
Hand Pump	
Air Conditioner	
Tube Light	
Fan	
Roof Light	
Bulb	

AREA	
AREA WITHIN BOUNDARY WALL	185928.87 Sft
AREA OF CLINICAL BLOCK	33377.22 Sft
PLINTH AREA OF BLOCK	33377.22 Sft

OPENING SCHEDULE OF DOORS AND WINDOWS					
DOORS	WIDTH	HEIGHT	WINDOWS	WIDTH	HEIGHT
D1	3'-6"	7'-0"	W1	4'-0"	5'-6"
D2	4'-0"	7'-0"	W2	4'-3"	8'-0"
D3	3'-0"	7'-0"	W3	8'-3"	8'-0"
D4	2'-6"	7'-0"	W4	2'-0"	2'-0"
D5	4'-6"	7'-0"	W5	4'-0"	4'-0"
D6	5'-0"	7'-0"	W6	5'-6"	8'-0"
D7	5'-4"	7'-0"	W7	6'-0"	4'-0"
D8	6'-0"	7'-0"	V1		
D9	7'-0"	7'-0"	V2		

Project:
**CAD MAPPING OF TEHSIL
HEAD QUARTER HOSPITALS,
PUNJAB**


Client:  GOVERNMENT OF THE PUNJAB PRIMARY & SECONDARY HEALTHCARE DEPARTMENT	Consultant:  SKAFS CONSULTANT (Pvt.) Limited <i>ENGINEERING AND ENVIRONMENT CONSULTANT</i>
--	---

Drawing Title:	THQ TAXILA
	CLINICAL BLOCK PLAN (PART 2)

Drawing No. SKAFS/TAXILA /10

CLINICAL BLOCK OF THQ HOSPITAL TAXILA

GROUND FLOOR PART 3

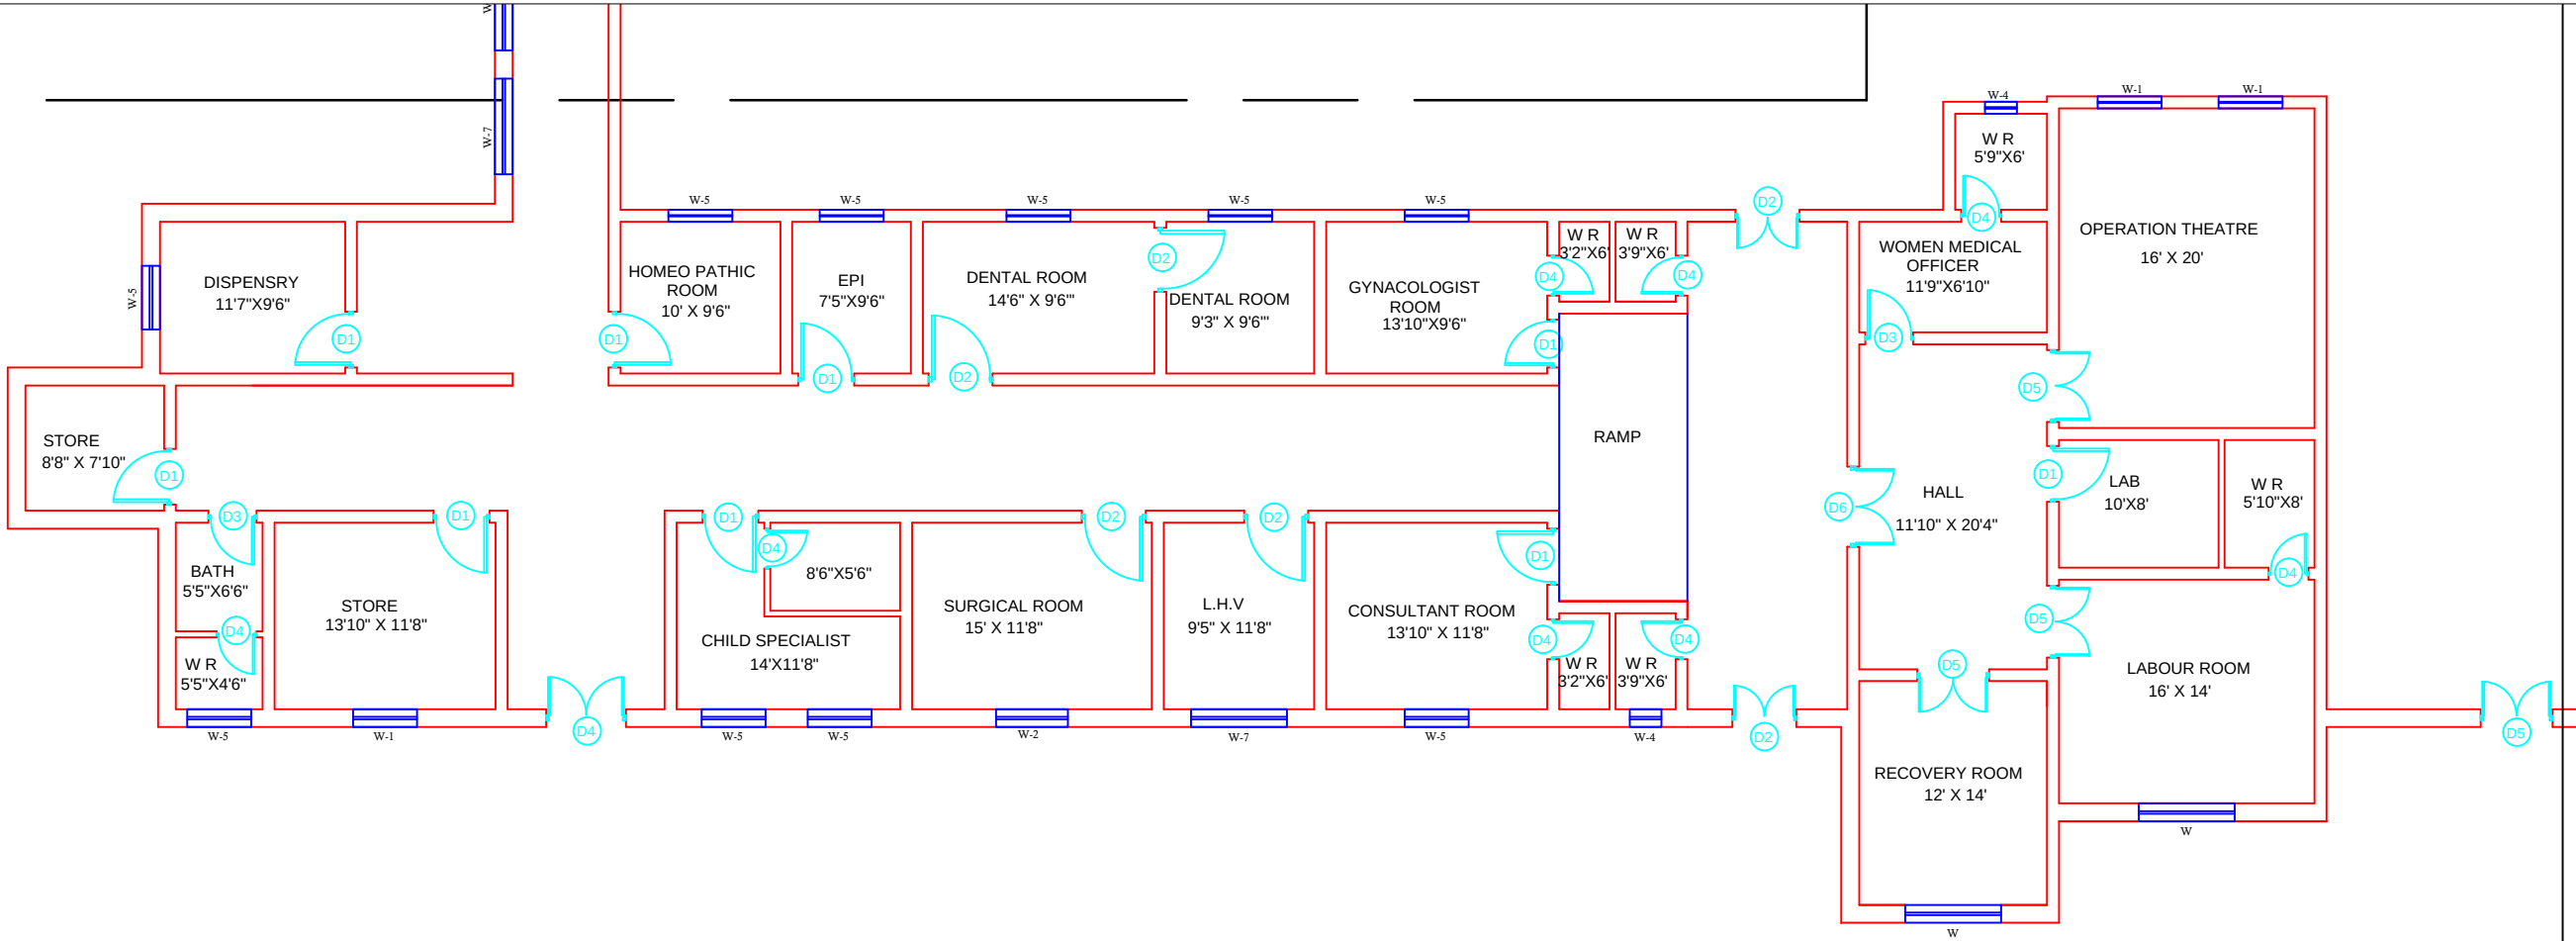

Legends:

Residential Area	
Road	
Wall	
Power Line	
OHT	
Tree	
Man Hole	
Tube Well	
Light Pole	
Lawns	
Earthen Areas	
Asphalts Roads	
Tough Pavers	
P.C.C / Plinth Protection	
Boundary Wall	
Brick Pavers / Soling	
Drain	
Tap	
Hand Pump	
Air Conditioner	
Tube Light	
Fan	
Roof Light	
Bulb	

AREA	
AREA WITHIN BOUNDARY WALL	185928.87 Sft
AREA OF CLINICAL BLOCK	33377.22 Sft
PLINTH AREA OF BLOCK	33377.22 Sft

OPENING SCHEDULE OF DOORS AND WINDOWS					
DOORS	WIDTH	HEIGHT	WINDOWS	WIDTH	HEIGHT
D1	3'-6"	7'-0"	W1	4'-0"	5'-6"
D2	4'-0"	7'-0"	W2	4'-3"	8'-0"
D3	3'-0"	7'-0"	W3	8'-3"	8'-0"
D4	2'-6"	7'-0"	W4	2'-0"	2'-0"
D5	4'-6"	7'-0"	W5	4'-0"	4'-0"
D6	5'-0"	7'-0"	W6	5'-6"	8'-0"
D7	5'-4"	7'-0"	W7	6'-0"	4'-0"
D8	6'-0"	7'-0"	V1		
D9	7'-0"	7'-0"	V2		

Project:
**CAD MAPPING OF TEHSIL
HEAD QUARTER HOSPITALS,
PUNJAB**


Client: GOVERNMENT OF THE PUNJAB PRIMARY & SECONDARY HEALTHCARE DEPARTMENT	Consultant: SKAFS CONSULTANT (Pvt.) Limited ENGINEERING AND ENVIRONMENT CONSULTANT
---	--

Drawing Title:
**THQ TAXILA
CLINICAL BLOCK PLAN (PART 3)**

Drawing No.
SKAFS/TAXILA /11

CLINICAL BLOCK OF THQ HOSPITAL TAXILA

GROUND FLOOR PART 4

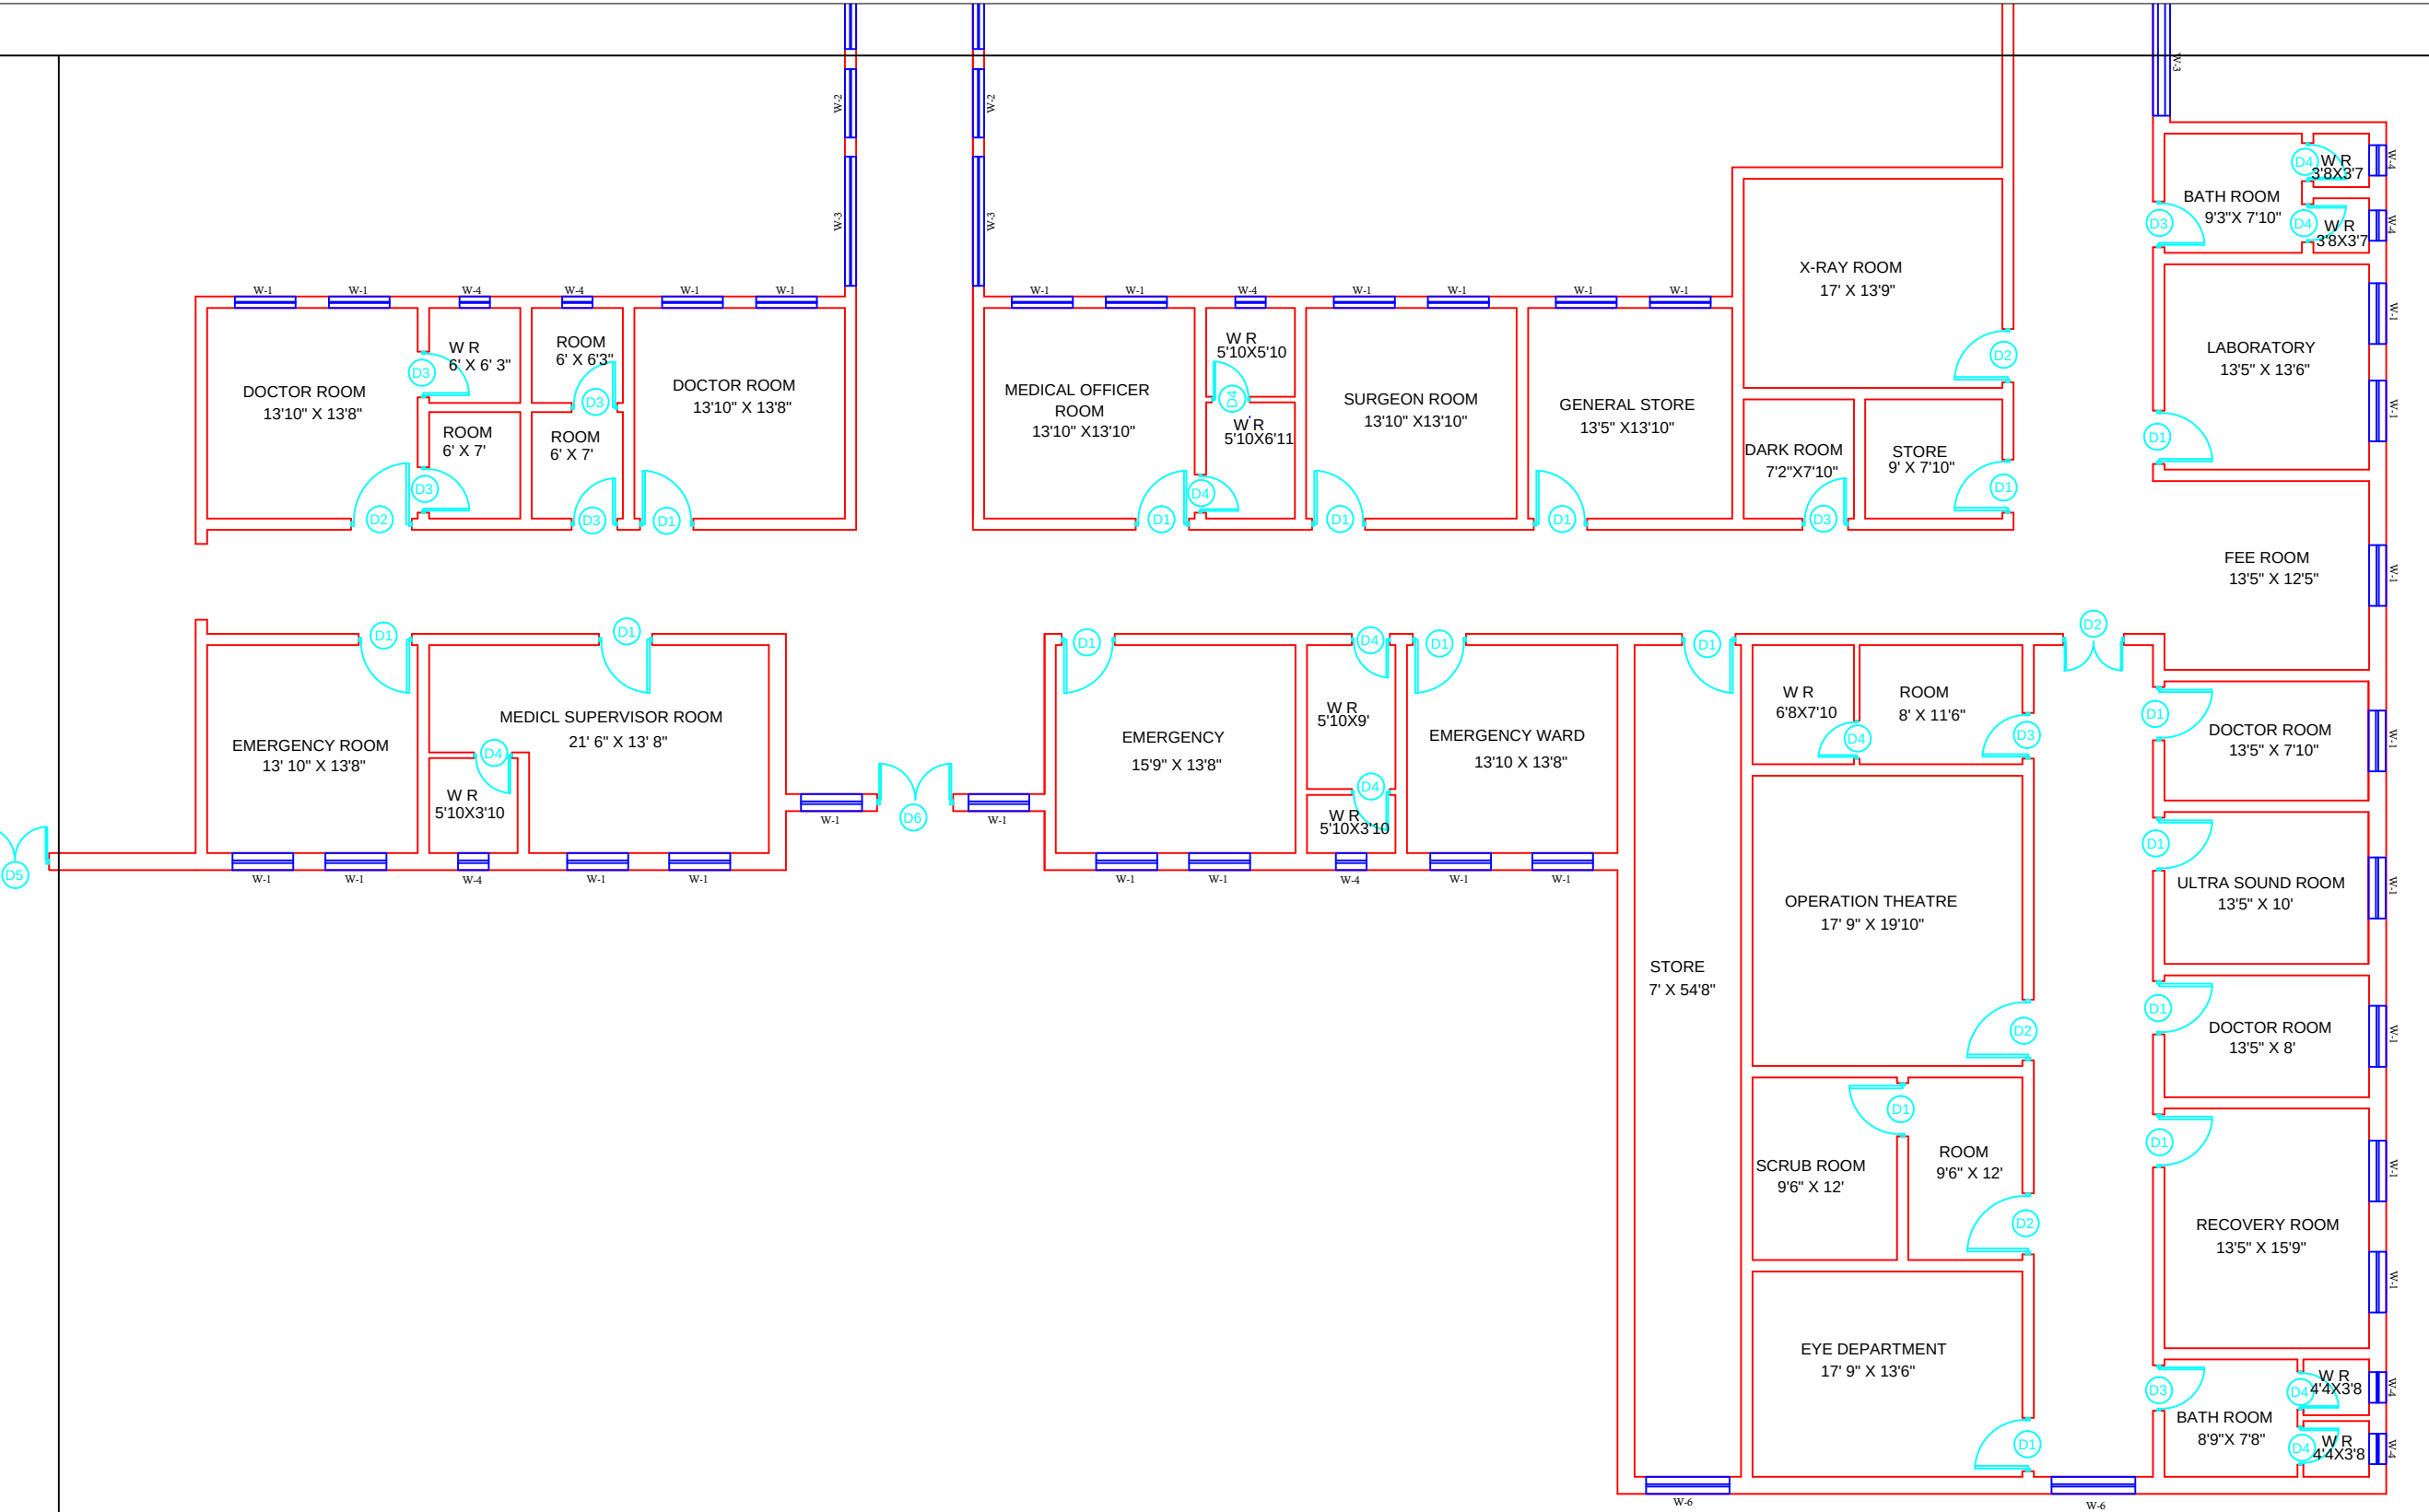

Legends:

Residential Area	
Road	
Wall	
Power Line	
OHT	
Tree	
Man Hole	
Tube Well	
Light Pole	
Lawns	
Earthen Areas	
Asphalts Roads	
Tough Pavers	
P.C.C / Plinth Protection	
Boundary Wall	
Brick Pavers / Soling	
Drain	
Tap	
Hand Pump	
Air Conditioner	
Tube Light	
Fan	
Roof Light	
Bulb	

AREA		
AREA WITHIN BOUNDARY WALL		185928.87 Sft
AREA OF CLINICAL BLOCK		33377.22 Sft
PLINTH AREA OF BLOCK		33377.22 Sft

OPENING SCHEDULE OF DOORS AND WINDOWS					
DOORS	WIDTH	HEIGHT	WINDOWS	WIDTH	HEIGHT
D1	3'-6"	7'-0"	W1	4'-0"	5'-6"
D2	4'-0"	7'-0"	W2	4'-3"	8'-0"
D3	3'-0"	7'-0"	W3	8'-3"	8'-0"
D4	2'-6"	7'-0"	W4	2'-0"	2'-0"
D5	4'-6"	7'-0"	W5	4'-0"	4'-0"
D6	5'-0"	7'-0"	W6	5'-6"	8'-0"
D7	5'-4"	7'-0"	W7	6'-0"	4'-0"
D8	6'-0"	7'-0"	V1		
D9	7'-0"	7'-0"	V2		


Project:	
CAD MAPPING OF TEHSIL HEAD QUARTER HOSPITALS, PUNJAB	
Client:	Consultant:
 GOVERNMENT OF THE PUNJAB PRIMARY & SECONDARY HEALTHCARE DEPARTMENT	 SKAFS CONSULTANT (Pvt.) Limited ENGINEERING AND ENVIRONMENT CONSULTANT

Drawing Title:	
THQ TAXILA CLINICAL BLOCK PLAN (PART 4)	
Drawing No.	

SKAFS/TAXILA	/ 12
--------------	------

ELECTRICAL LAYOUT PLAN OF THQ HOSPITAL TAXILA

GROUND FLOOR

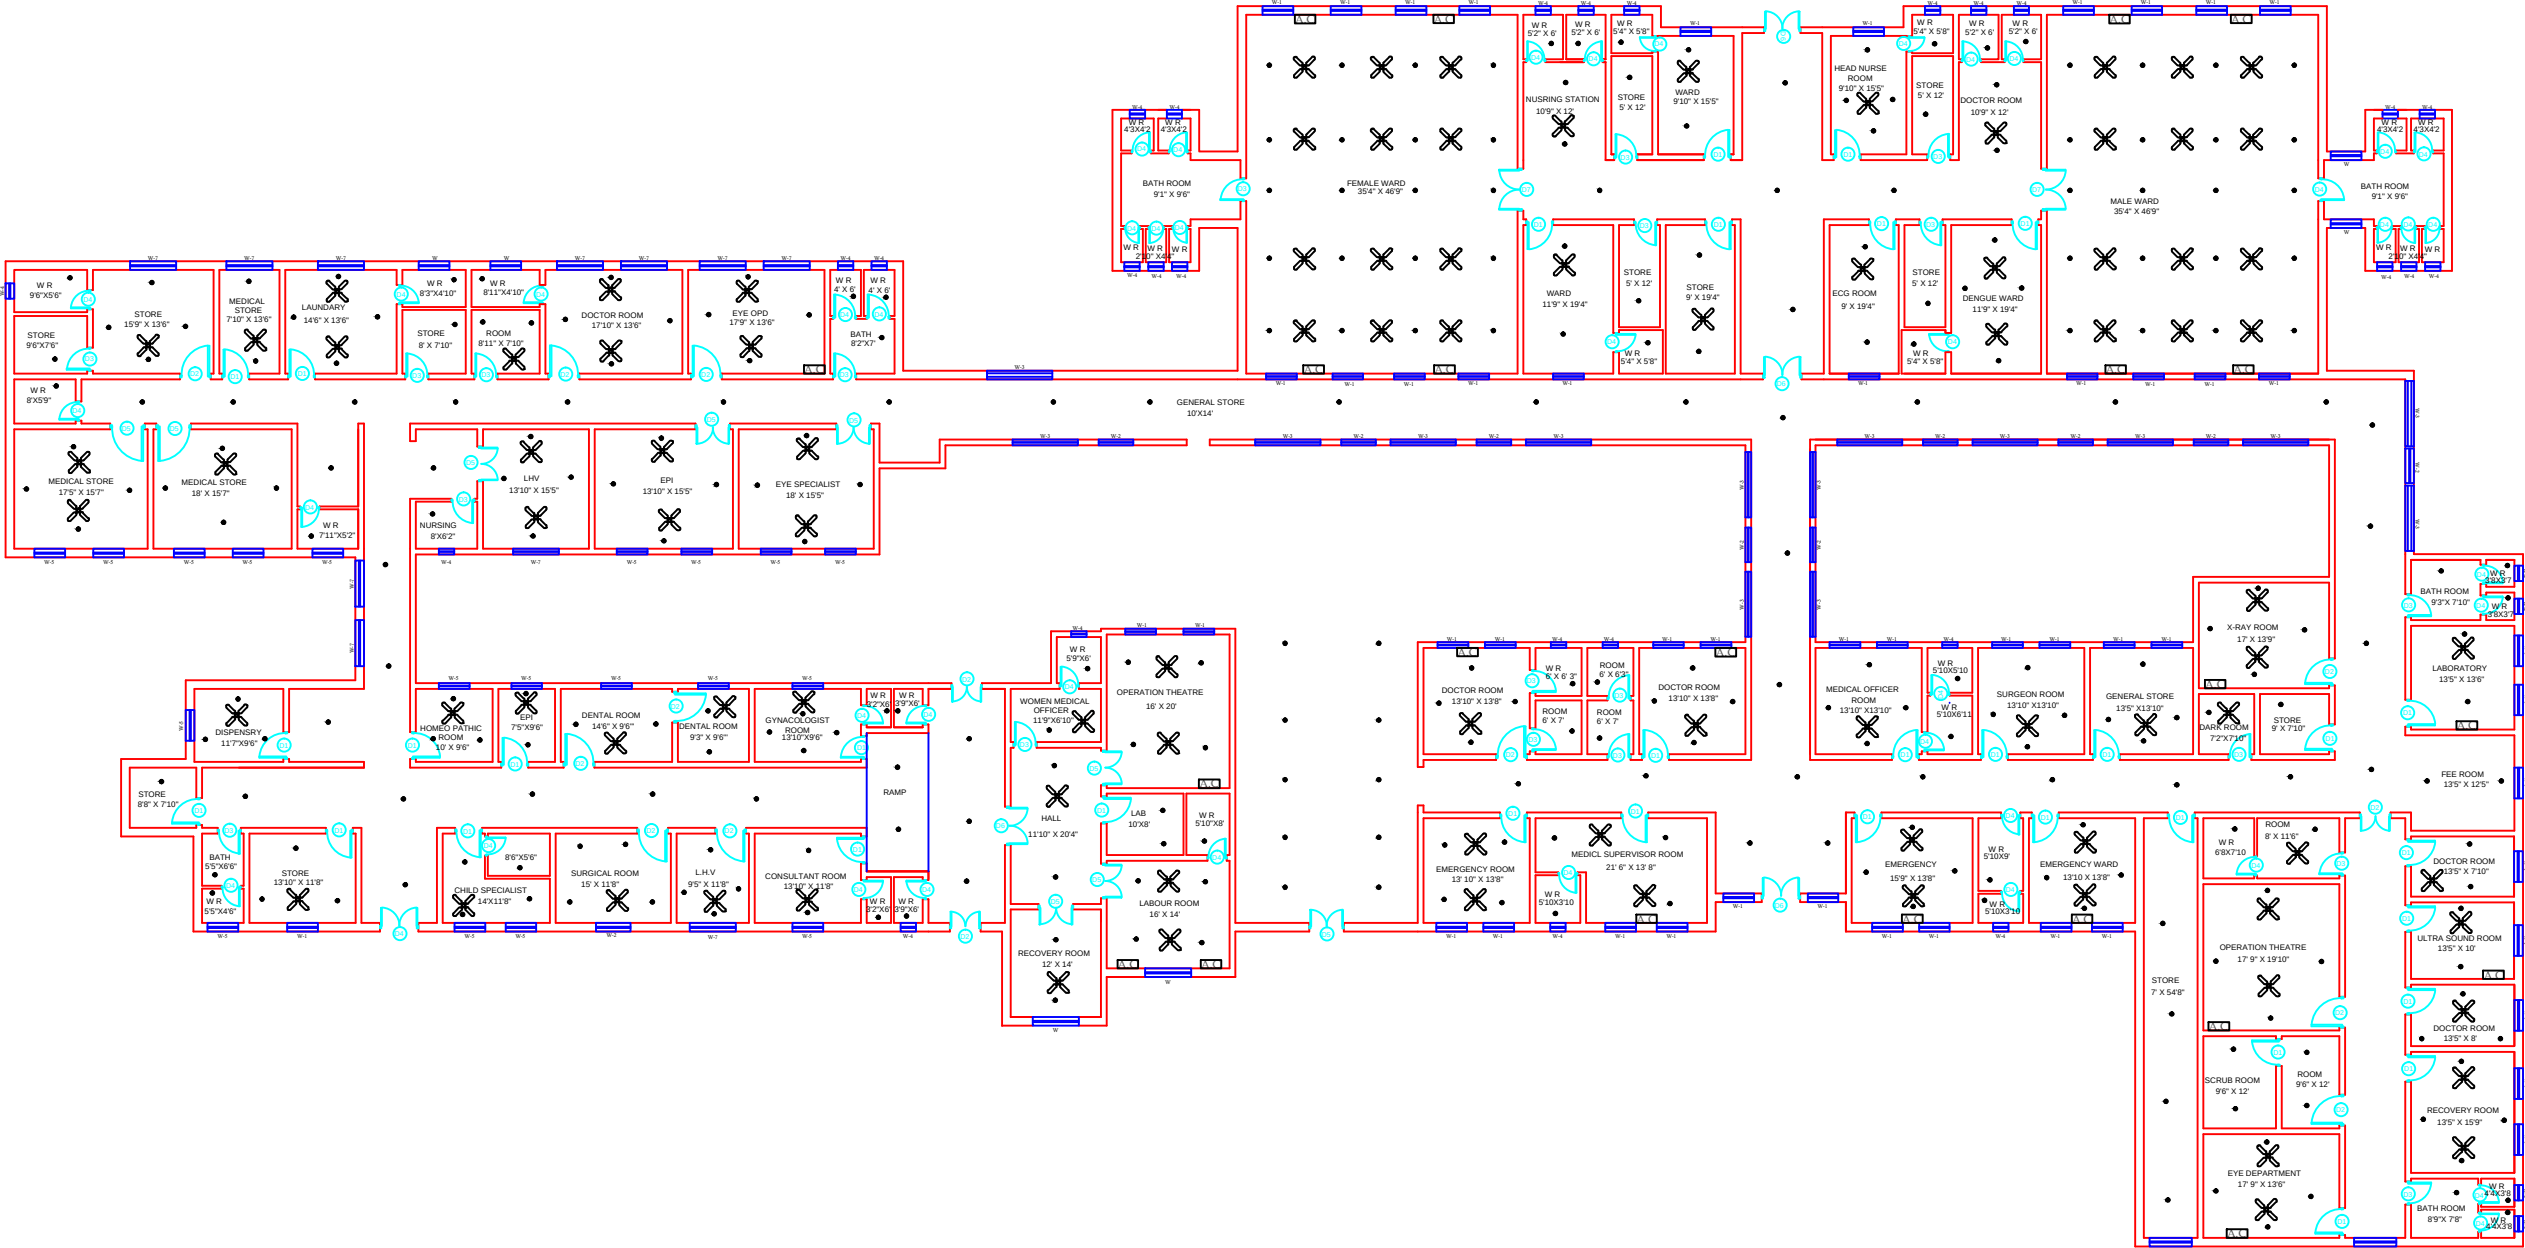

Legends:

Residential Area	
Road	
Wall	
Power Line	
OHT	
Tree	
Man Hole	
Tube Well	
Light Pole	
Lawns	
Earthen Areas	
Asphalts Roads	
Tough Pavers	
P.C.C / Plinth Protection	
Boundary Wall	
Brick Pavers / Soling	
Drain	
Tap	
Hand Pump	
Air Conditioner	
Tube Light	
Fan	
Roof Light	
Bulb	

AREA					
AREA WITHIN BOUNDARY WALL			185928.87 Sft		
AREA OF CLINICAL BLOCK			33377.22 Sft		
PLINTH AREA OF BLOCK			33377.22 Sft		
OPENING SCHEDULE OF DOORS AND WINDOWS					
DOORS	WIDTH	HEIGHT	WINDOWS	WIDTH	HEIGHT
D1	3'-6"	7'-0"	W1	4'-0"	5'-6"
D2	4'-0"	7'-0"	W2	4'-3"	8'-0"
D3	3'-0"	7'-0"	W3	8'-3"	8'-0"
D4	2'-6"	7'-0"	W4	2'-0"	2'-0"
D5	4'-6"	7'-0"	W5	4'-0"	4'-0"
D6	5'-0"	7'-0"	W6	5'-6"	8'-0"
D7	5'-4"	7'-0"	W7	6'-0"	4'-0"
D8	6'-0"	7'-0"	V1		
D9	7'-0"	7'-0"	V2		

Project:

CAD MAPPING OF TEHSIL
HEAD QUARTER HOSPITALS,
PUNJAB

Client:



GOVERNMENT OF THE PUNJAB
PRIMARY & SECONDARY
HEALTHCARE DEPARTMENT

Consultant:



SKAFS CONSULTANT (Pvt.)
Limited
ENGINEERING AND ENVIRONMENT
CONSULTANT

Drawing Title:

THQ TAXILA
ELECTRICAL PLAN (GROUND FLOOR)

Drawing No.

SKAFS/TAXILA /13